
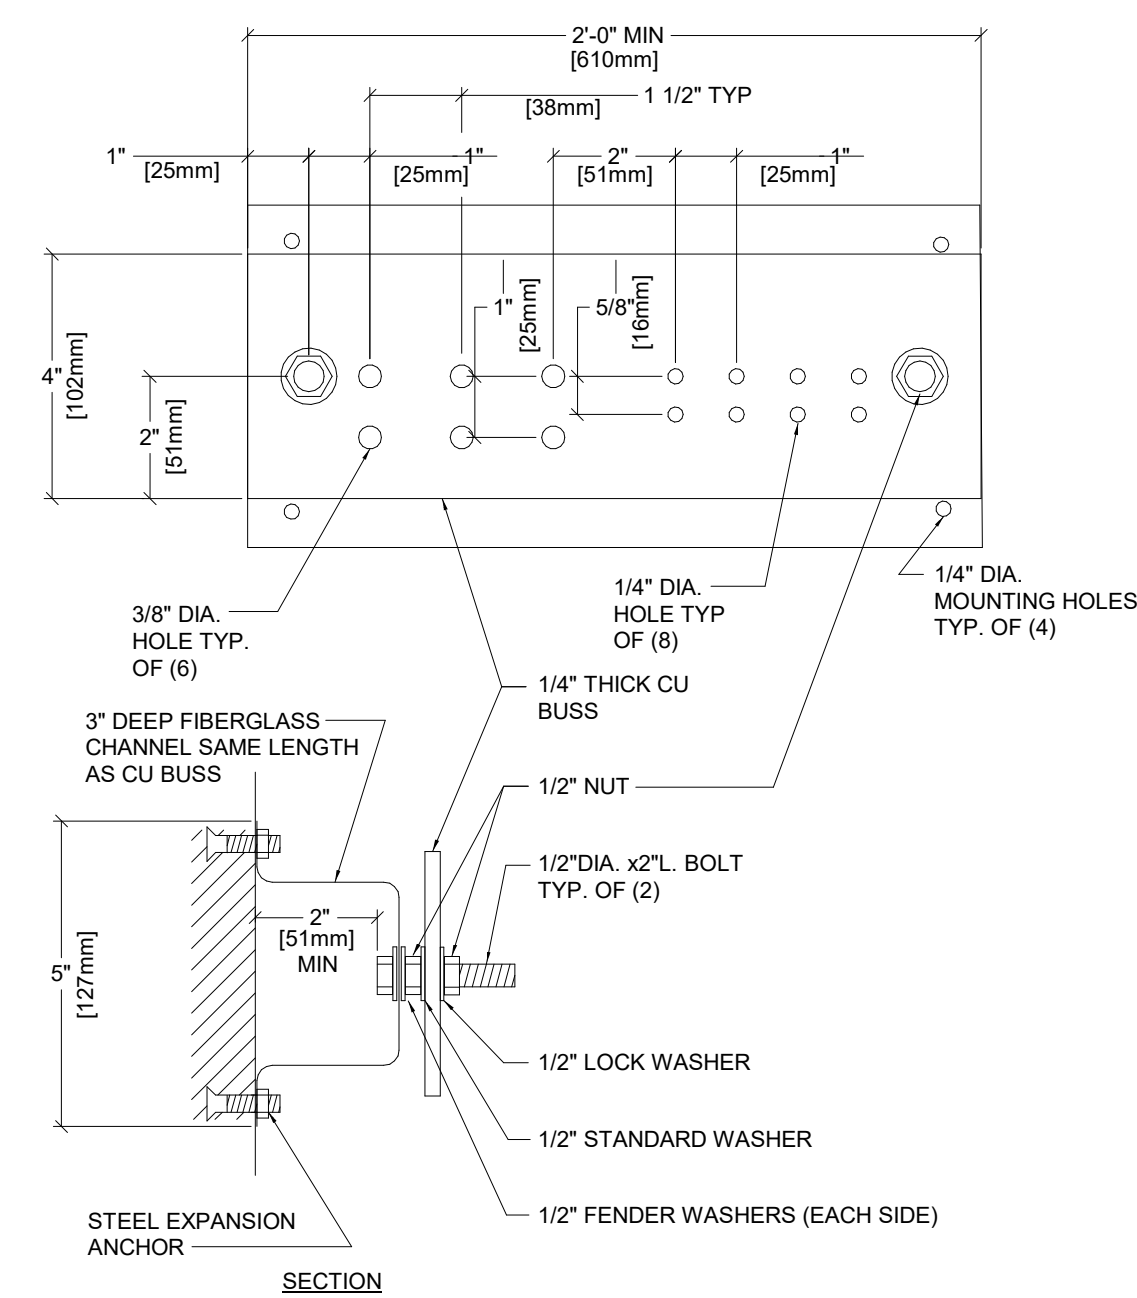
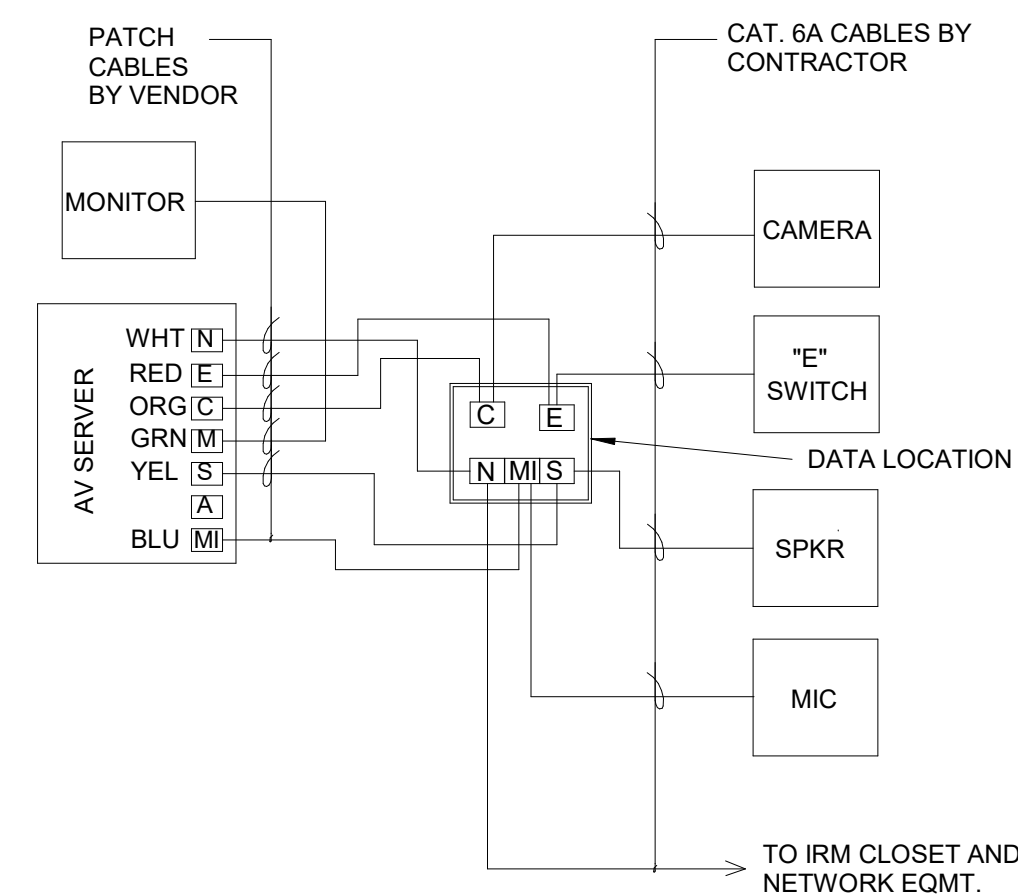


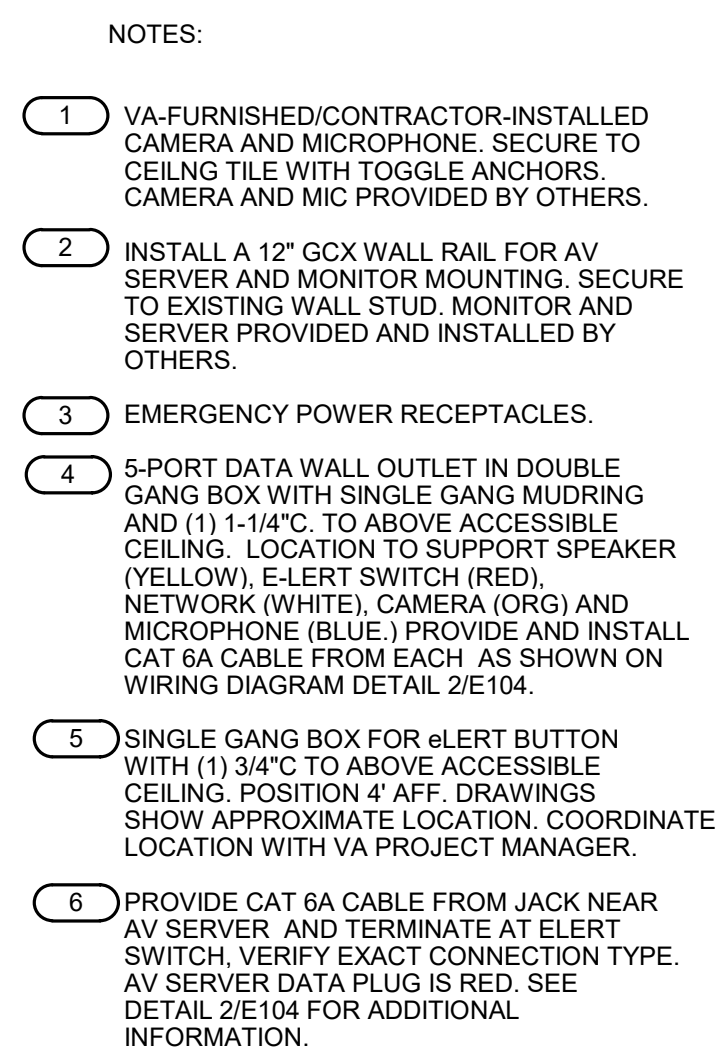

GENERAL NOTES

1. ALL HARDWARE SHOWN SHALL BE STAINLESS STEEL.
2. PROVIDE 1 MOUNTING POINT PER 12" OF BAR LENGTH
3. HOLES MAY BE ADDED IF REQUIRED.

TELECOMMUNICATIONS ROOM GROUND BAR DETAIL
(TYPICAL OF RM. 250 & RM. 252)

CP-2		CP-1A (CP-3)	SPARE 175A	MOTOR SAVERS
	SPACE			
CP-1	SPARE 2 • SPEED STARTER	AH-3		
AHU-2 RTN FAN 60A/3P F @ 35A		SPARE	CP-1B (CP-4)	
		RE-3	SPARE 90A	
			113-MA/PP 90A	
AHU-2 SUPPLY FAN 100A/3P F @ 100A		CIRC PUMP #1 CONDENSATE	PNL PCEQ1 50A	
	MAIN LUGS	SPARE 90A		
		SPACE		

4 EXISTING MOTOR CONTROL CENTER PMCCQ
1/4" = 1'-0"

CP-2		SPARE	SPARE 175A	MOTOR SAVERS
	SPACE			
CP-1	SPARE 2 - SPEED STARTER	SPARE		
AHU-2 RTN FAN 60A3P F @ 35A		SPARE	SPARE	
		SPARE	SPARE 90A	
			113-MA3P 90A	
AHU-2 SUPPLY FAN 100A3P F @ 100A	SPARE 2 - SPEED STARTER	CIRC PUMP #1 CONDENSATE	PNL PCE01 50A	
		MAIN LUGS	SPARE 90A	
				SPACE

5 REVISED MOTOR CONTROL CENTER PMCCEQ
1/4" = 1'-0"

[illegible]

STRUCTURAL: Albertson Engineering Inc. Albertson Engineering, Inc. 3202 W. Main St., #C Rapid City, South Dakota 57702 Phone: 605-343-9606	MECHANICAL / ELECTRICAL / PLUMBING: West Plains Engineering, Inc. 1750 Rand Road Rapid City, South Dakota 57702 Phone: 605-348-7455
--	--

A/E:
STONE GROUP ARCHITECTS, INC
319 N. MAIN AVE.
SIoux FALLS, SD 57104
605.271.1144
TODD STONE, AIA



Office of
Construction
and Facilities
Management



U.S. Department
of Veterans Affairs

Drawing Title	ELECTRICAL DETAILS
---------------	--------------------

Approved:

Phase

FULLY SPRINKLERED

Project Title	RENOVATE AND CONSOLIDATE HEATING FUNCTIONS
---------------	---

Location	FORT MEADE, SOUTH DAKOTA
----------	--------------------------

Issue Date
06/10/2022

Checked
MPS

Drawn	VI S
-------	------

Project Number	VA #568-14-110 WPE #BR21020
Building Number	113

	Drawing Number
--	----------------

EJ102

1		2		3											
1SC2															
VOLTS:		120/208 Wye		PHASES:		3		WIRE:		4		MAIN CAPACITY:		100 A	
A/C RATING:				LOCATION:				ELEC ECIG				MAIN CONNECTION:		MLO	
MOUNTING:		SURFACE		FEEDER SIZE:				SEE ELECTRICAL ONE-LINE DIAGRAM				MAIN TYPE:		TYPE 1	
CKT	ITEM FED	WIRE SIZE	AMPS	POLES	A (WATTS)	B (WATTS)	C (WATTS)	POLES	AMPS	WIRE SIZE	ITEM FED	CKT			
1	WORK RM 187DA REC	12	20	1	0	0		1	20	12	LIFE SUPPORT REC	2			
3	WORK RM 187DA REC	12	20	1		0	0	1	20	12	LIFE SUPPORT REC	4			
5	MAS 187D REC	12	20	1			0	0	1	20	MED COL LIFE SUPPORT	6			
7	MAS 187E REC	12	20	1	0	0		1	20	12	VIEW BOX LIFE SUPPORT REC	8			
9	NURSE CALL	12	20	1		0	0	1	20	12	CRASH CART LIFE SUPPORT	10			
11	NURSE STA 1871 REC	12	20	1			0	0	1	20	TABLE LIFE SUPPORT	12			
13	NURSE STA 1871 REC	12	20	1	0	0		1	20	12	PATIENT WALL 187S REC	14			
15	NURSE STA 1871 REC	12	20	1		0	0	1	20	12	PATIENT WALL 187R REC	16			
17	NURSE STA 1871 REC	12	20	1			0	0	1	20	PATIENT WALL 187Q REC	18			
19	CLEAN/INMED UNIT REC	12	20	1	0	0		1	20	12	N.S. EXAM CORR LTG	20			
21	EXAM 187G REC	12	20	1			0	0	1	20	PAT BED/CONTR/BLACK LTG	22			
23	EXAM 187G REC	12	20	1				1	20	12	LIFE SUPPORT LTG	24			
25	CORRIDOR REC	12	20	1	0	840		1	20	12	CORR. C100DB DGR ACTUATOR	26			
27	TELE TRIAGE REC	12	20	1			0	0	1	20	SPARE	28			
29	EMERGENCY SIGN	12	20	1				0	0	1	SPARE	30			
TOTAL CONNECTED LOAD:					840 W	0 W	0 W	AMPS:	2 A	LOAD:	840 W				

1SN14		VOLTS: 120/208 Wye		PHASES: 3		WIRE: 4		MAIN CAPACITY: 22.5					
		A/C RATING:		LOCATION:		ELEC EC'G		MAIN CONNECTION: MLO					
		MOUNTING:		SURFACE		FEEDER SIZE:		MAIN TYPE: TYPE 1					
OKT	ITEM FED	WIRE SIZE	AMPS	POLES	A (WATTS)	B (WATTS)	C (WATTS)	POLES	AMPS	WIRE SIZE	ITEM FED	OKT	
1	WAITING RM 188 EWC RECEPT	12	20 A	1	1200	0		1	20 A	12	EXAMMED/TOILET REC	2	
3	MAS CORR/WAIT 188 RECEPTS	12	20 A	1			900	0	1	20 A	12	HEADWALL 187S REC	4
5	MAS CORR/WAIT C100RD...	12	20 A	1			720	0	1	20 A	12	HEADWALL 187R REC	6
7	MAS 100B RECEPTS	12	20 A	1	1260	0			1	20 A	12	HEADWALL 187Q REC	8
9	MAS 188A REC	12	20 A	1		0	0	0	1	20 A	12	EXAM 187S REC	10
11	MAS 188A REC	12	20 A	1			0	0	1	20 A	12	EXAN 187R REC	12
13	EXT/WAIT/COHR REC/CUH-	12	20 A	1	0	0			1	20 A	12	EXAM 187Q REC	14
15	TOILET/VENT/ISSK REC/REC	12	20 A	1		0	0		1	20 A	12	TELE-TRIAGE REC	16
17	C100RD VENDING RECEPT	12	20 A	1			1000	0	1	20 A	12	SOILED UTIL REC/CUH-	18
19	C100RD VENDING RECEPT	12	20 A	1	1000	0			1	20 A	12	AUTO DOORS	20
21	WAITING RM 188 COFFEE REC	12	20 A	1			1500	0	1	20 A	12	NOURILKRS/VEST REC/CUH-	22
23	URGENT CARE NON-CRIT LTG	12	20 A	1			0	0	1	20 A	12	CORR C100D LTG	24
25	MAS CORR/OFFICE LTG	12	20 A	1	0	0			1	20 A	-	SPARE	26
27	MAS WAITING LTG	12	20 A	1		0	0		1	20 A	-	SPARE	28
29	OFFIC/CLASS 184,185	12	20 A	1			0	0	1	20 A	-	SPARE	30
31	EF-11,12	12	20 A	1	0	0			1	20 A	12	MED COLUMN LIFE SUPPORT	32
33	AUTO DOORS C100RA	12	20 A	1		0	0		1	20 A	12	BLANKET WARMER	34
35	AUTO DOORS C100DA	12	20 A	1			0	360	1	20 A	12	ELEV EL5 EQUIP RECEPTS	36
37	EF-10 (NOTE 1)	12	20 A	1	400	0			1	20 A	12	MICOWAVE	38
39	MAS 188A RECEPTS	12	20 A	1		900	0		1	20 A	12	COUNTER REC - 187N	40
41	SPARE	-	20 A	1			0	0	1	20 A	12	REFRIGICE MAKER	42
TOTAL CONNECTED LOAD:					3860 W	3300 W	2080 W	AMPS:	26 A	LOAD:	19240 W		

NOTE:
1. NEW LOAD CONNECTED TO EXISTING BREAKER.

EX. 2CC1		VOLTS: 120/208 Wye		PHASES: 3		LOCATION: ELEC ECB2		WIRE: 4		MAIN CAPACITY: 225 A		
AIRC RATING: MOUNTING:		SURFACE		FEEDER SIZE:		SEE ELECTRICAL ONE-LINE DIAGRAM				MAIN CONNECTION: MLO		
CKT	ITEM FED	WIRE SIZE	AMPS	POLES	A (WATTS)	B (WATTS)	C (WATTS)	POLES	AMPS	WIRE SIZE	ITEM FED	CKT
1	RECOVERY LIGHTS	-	20 A	1	0 0 0				1 20 A	-	NURSE STA., MEDICATION LTS.	2
3	HEADWALL RM 280	-	20 A	1		0 0			1 20 A	-	ELECT. RM. OUTLETS TC2A	4
5	CORR. RECOVERY LTS.	-	20 A	1			0 0		1 20 A	-	CONTROL RM OUTLETS	6
7	RECOVERY NURSE STA. OUTLETS	-	20 A	1	0 0 0				1 20 A	-	CONTROL RM OUTLETS	8
9	RECOVERY NURSE STA. OUTLETS	-	20 A	1		0 0			1 20 A	-	E.M. OUTLET RM 200	10
11	SPARE	-	20 A	1			0 0		1 20 A	-	NRSE STA CTR CNSL REC (NOTE 12)	12
13	CORRIDOR OUTLETS	-	20 A	1	0 0 0				1 20 A	-	EF-9 (BREAKER OFF)	14
15	CRASH CART OUTLET	-	20 A	1		0 0			1 20 A	-	EF-9	16
17	MED. REFRIG./FREEZER	-	20 A	1			0 0		1 20 A	-	INTERCOM P.S. (NOTE 1)	18
19	TURNUED OFF	-	100 A	2	0 0 0				1 20 A	-	RM 208 OUTLETS	20
21						0 0						22
23	RM 200 WEST WALL		20 A	1					2 20 A	-	NURSE CALL P.S. (NOTE 1)	24
25					0 0 0				1 20 A	-	SPARE	26
27	PANEL 1EC1 (NOTE 1)		100 A	3		0 0			1 20 A	-	SPARE	28
29							0 0		1 20 A	-	SPARE	30
31					0 0 0							32
33	PANEL 2EC1 (NOTE 1)		100 A	3		0 0			3 100 A	-	PANEL 2SC1 (NOTE 1)	34
35							0 0					36
37	RM 200 WEST WALL		20 A	1	0 0 0							38
39	RM 200 WEST WALL		20 A	1		0 0			3 50 A	-	PORT LAZER	40
41	FRONT NURSES STATION OUTLET		20 A	1			0 0					42
TOTAL CONNECTED LOAD:					0 W	0 W	0 W	AMPS: 0 A		LOAD: 0 W		
1. CIRCUIT WILL NOT BE DEMOED AND MUST BE MAINTAINED CONTINUOUS EXCEPT FOR OUTAGE TO REPLACE PANEL.												

EX. 2CLS			VOLTS: 120/208 Wye		PHASES: 3		WIRE: 4		MAIN CAPACITY: 125 A				
			A/C RATING:	LOCATION:		STAIR B ST2B		MAIN CONNECTION: MLO					
			MOUNTING:		FEEDER SIZE:		SEE ELECTRICAL ONE-LINE DIAGRAM			MAIN TYPE: MLO			
CKT	ITEM FED	WIRE SIZE	AMPS	POLES	A (WATTS)	B (WATTS)	C (WATTS)	POLES	AMPS	WIRE SIZE	ITEM FED	CKT	
1	NORTH CORRIDOR LTS.	- 20 A	1	0	0			1	20 A	-	NITROGEN CHANGE OVER...	2	
3	SOUTH CORRIDOR LTS.	- 20 A	1			0	0	1	20 A	-	MED. GAS ALARM PANELS...	4	
5	??	- 20 A	1				0	0	1	20 A	-	NURSE STA MED GAS ALARM	6
7	SPARE	- 20 A	1	0	0			1	20 A	-	SPARE (BREAKER TURNED ON)	8	
9	SPARE	- 20 A	1			0	0	1	20 A	-	MED GAS ALARM (TURNED OFF)	10	
11	SPARE	- 20 A	1				0	0	1	20 A	-	EXIT AND EMERGENCY...	12
TOTAL CONNECTED LOAD:					0 W	0 W	0 W	AMPS: 0 A	LOAD: 0 W				

EX. 2CN1		VOLTS:		120/208 Wye		PHASES:		3		WIRE:		4		MAIN CAPACITY:		225 A	
		A/C RATING:		MOUNTING:		LOCATION:		FEEDER SIZE:		SEE ELECTRICAL ONE-LINE DIAGRAM		ELEC EC2B		MAIN CONNECTION:		MLO	
																MLO	
OKT	ITEM FEO	WIRE SIZE	AMP	POLES	A (WATTS)	B (WATTS)	C (WATTS)	POLES	AMPS	WIRE SIZE	ITEM FEO	OKT					
1	LOCKER ROOM LIGHTS	--	20 A	1	0 0				1	20 A	-	CORRIDOR LIGHTS	2				
3	CONTROL LIGHTS	--	20 A	1		0 0			1	20 A	-	EAST CORR. LIGHTS	4				
5	ANESTH. OFFICE LIGHTS	--	20 A	1			0 0		1	20 A	-	NURSE STATION LIGHTS	6				
7	HEADWALL RM 280 LIGHTS	--	20 A	1	0 0				1	20 A	-	MEDICATION, MISC. LIGHTS	8				
9	HEADWALL 261 BED	--	20 A	1		0 0			1	20 A	-	SPARE-TURNED OFF	10				
11	HEADWALL OUTLETS.	--	20 A	1			0 0		1	20 A	-	SPARE	12				
13	O.R. SUPERVISOR OUTLETS	--	20 A	1	0 0				1	20 A	-	CLOSET OUTLET	14				
15	ANESTH. OFFICE OUTLETS	--	20 A	1		0 0			1	20 A	-	CONTROL ROOM OUTLETS	16				
17	OFFICE CHIEF OUTLETS	--	20 A	1					0 0	1	20 A	-	CLEAN UTILITY OUTLETS	18			
19	VISITORS' OUTLETS	--	20 A	1	0 0				1	20 A	-	E.W. COOLER	20				
21	NURSE STA. OUTLETS	--	20 A	1		0 0			1	20 A	-	WARNING CABINET	22				
23	SPACE	--	--	--			0 0		--	--	--	SPACE	24				
25	NURSE STATION OUTLETS	--	20 A	1	0 0				--	--	--	SPACE	26				
27	MEDICATION OUTLETS	--	20 A	1		0 0			1	20 A	-	NURSE STA. OUTLETS	28				
29	WARD RM 261 OUTLETS	--	20 A	1			0 0		1	20 A	-	NURSE STA. OUTLETS	30				
31	SPACE	--	--	--	0 0				1	20 A	-	SPACE	32				
33	SPACE	--	--	--		0 0			1	20 A	-	RECEPT. DIVID.-WALL RM 200	34				
35	SPACE	--	--	--			0 0		1	20 A	-	SPACE	36				
37	SPACE	--	--	--	0 0				2	30 A	-	A/C ENDOSCOPY	38				
39	SPACE	--	--	--		0 0			--	--	--	SPACE	40				
41	SPACE	--	--	--			0 0		--	--	--	SPACE	42				
TOTAL CONNECTED LOAD:					0 W	0 W	0 W	AMPS:	0 A	LOAD:	0 W						

EX. 2EC1			VOLTS:		120/208 Wye		PHASES:		3		WIRE:		4		MAIN CAPACITY:		225 A	
			A/C RATING:				LOCATION:				ELEC EC2C				MAIN CONNECTION:		MLO	
			MOUNTING:				FEEDER SIZE:				SEE ELECTRICAL ONE-LINE DIAGRAM				MAIN TYPE:		MLO	
CKT	ITEM FED	WIRE SIZE	AMPS	POLES	A (WATTS)	B (WATTS)	C (WATTS)	POLES	AMPS	WIRE SIZE	MAIN TYPE		CKT					
1	WARD TOILET LIGHTS	-	20 A	1	0	0			1	20 A	HEADWALL 217, 206		2					
3	HEADWALL 202, 203	-	20 A	1		0	0		1	20 A	HEADWALL 218, 219		4					
5	HEAD WALL 202, 222	-	20 A	1			0	0	1	20 A	CORRIDOR OUTLETS		6					
7	NURSE CALL SYSTEM	-	20 A	1	0	0			1	20 A	NOURISHMENT OUTLETS		8					
9	SPARE	-	20 A	1		0	0		1	20 A	SPARE		10					
11	NOURISHMENT CENTER	-	50 A	2		0	0		0	1	20 A	SPARE		12				
13	SPACE	--	--	--		0	0		1	20 A	SPACE		14					
15	SPACE	--	--	--			0	0	--	--	SPACE		16					
17	SPACE	--	--	--			0	0	--	--	SPACE		18					
19	SPACE	--	--	--	0	0			--	--	SPACE		20					
21	SPACE	--	--	--		0	0		--	--	SPACE		22					
23	SPACE	--	--	--			0	0	--	--	SPACE		24					
25	SPACE	--	--	--	0	0			--	--	SPACE		26					
27	SPACE	--	--	--		0	0		--	--	SPACE		28					
29	SPACE	--	--	--			0	0	--	--	SPACE		30					
TOTAL CONNECTED LOAD:					0 W	0 W	0 W	AMPS:	0 A	LOAD:	0 W							

EX. 2EN1		VOLTS: 120/208 Wye		PHASES: 3		WIRE: 4		MAIN CAPACITY: 225 A					
		A/C RATING:		LOCATION:		ELEC EC2C		MAIN CONNECTION: MLO					
		MOUNTING:		SURFACE		FEEDER SIZE:		SEE ELECTRICAL ONE-LINE DIAGRAM					
CKT	ITEM FED	WIRE SIZE	AMPS	POLES	A (WATTS)	B (WATTS)	C (WATTS)	POLES	AMPS	WIRE SIZE	ITEM FED	CKT	
1	WARD LIGHTS RM 205-208	-	20 A	1	0	0			1	20 A	WARD LIGHTS RM 217-22X	2	
3	WARD LIGHTS RM 209-213	-	20 A	1			0	0	1	20 A	HEADWALL 232 BED	4	
5	WARD LIGHTS RM 201-203	-	20 A	1				0	0	1	20 A	HEADWALL 232 LTS	6
7	HEADWALL 243 REC.	-	20 A	1	0	0			1	20 A	HEADWALL 232 REC.	8	
9	HEADWALL 243 BED	-	20 A	1			0	0	1	20 A	HEADWALL 228, 229 BED	10	
11	HEADWALL 243 LIGHTS	-	20 A	1			0	0	1	20 A	HEADWALL 228, 229 LTS	12	
13	HEADWALL 245 REC.	-	20 A	1	0	0			1	20 A	HEADWALL 228, 229 REC.	14	
15	HEADWALL 245 BED	-	20 A	1			0	0	1	20 A	HEADWALL 222, 228 LTS	16	
17	HEADWALL 245 LIGHTS	-	20 A	1			0	0	1	20 A	HEADWALL 222, 228 LTS	18	
19	WARD 206 OUTLETS	-	20 A	1	0	0			1	20 A	HEADWALL 222, 228 REC.	20	
21	E.W.C.	-	20 A	1			0	0	1	20 A	WARD 217 OUTLETS	22	
23	BATH TOILET OUTLETS	-	20 A	1				0	0	1	20 A	DAYROOM OUTLETS	24
25	CLASSROOM OUTLETS	-	20 A	1	0	0			1	20 A	WARD 218 OUTLETS	26	
27	STORAGE OUTLETS	-	20 A	1			0	0	1	20 A	WARD 219 OUTLETS	28	
29	STORAGE OUTLETS	-	20 A	1				0	0	1	20 A	BEDPAN STERILIZER	30
31	WARD 203 OUTLETS	-	20 A	1	0	0			1	20 A	WARD 222 OUTLETS	32	
33	WARD 202 OUTLETS	-	20 A	1			0	0	1	20 A	HYDRO TUB GFI (NOTE 1)	34	
35	WARMING CABINET	-	20 A	1				0	0	1	20 A	EF-5 & EF-6	36
37	EF-11	-	20 A	1	0	0			1	20 A	SPARE	38	
39	SPARE	-	20 A	1			0	0	1	20 A	SPARE	40	
41	SPARE	-	20 A	1				0	0	1	20 A	SPARE	42
		TOTAL CONNECTED LOAD:			0 W	0 W	0 W	AMPS: 0 A		LOAD: 0 W			
NOTE 1: GFI BREAKER													

EX. 25C1				VOLTS: 120/208 Wye		PHASES: 3		WIRE: 4		MAIN CAPACITY: 225 A			
A/C RATING: MOUNTING:				SURFACE		LOCATION: FEEDER SIZE:		ELEC EC2D SEE ELECTRICAL ONE-LINE DIAGRAM		MAIN CONNECTION: MLO			
CKT	ITEM FED	WIRE SIZE	AMPS	POLES	A (WATTS)	B (WATTS)	C (WATTS)	POLES	AMPS	WIRE SIZE	ITEM FED	CKT	
1	WARD BATH LIGHTS	- 20 A	1		0	0			1	20 A	-	HEADWALL 249-253	2
3	HEADWALL 225-226, 229	- 20 A	1			0	0		1	20 A	-	CORRIDOR OUTLETS	4
5	EF-3 RM 268	- 20 A	1				0	0	1	20 A	-	NOURISHMENT OUTLETS	6
7	LTS IN ISOLATION COMMON AREA	- 20 A	1		0	0			1	20 A	-	RM 274 IU	8
9	ISOLATION EXHAUST FAN	- 20 A	1			0	0		1	20 A	-	RM 274 IU	10
11	HEAD BOARDS 262	- 20 A	1				0	0	1	20 A	-	SPARE	12
13					0	0			--	--	--	SPACE	14
15	NOURISHMENT CENTER	- 40 A	3			0	0		1	20 A	-	262 EN-OUTLETS	16
17							0	0	1	20 A	-	262 EN-OUTLETS	18
19	NOURISHMENT CENTER	- 50 A	2						--	--	--	SPACE	20
21		--	--	--		0	0		--	--	--	SPACE	22
23	SPACE	--	--	--			0	0	--	--	--	SPACE	24
25	SPACE	--	--	--	0	0			--	--	--	SPACE	26
27	SPACE	--	--	--			0	0	--	--	--	SPACE	28
29		--	--	--			0	0	--	--	--	SPACE	30
TOTAL CONNECTED LOAD:					0 W		0 W		0 W	AMPS: 0 A	LOAD: 0 W		

EX. 2SN1		VOLTS: 120/208 Wye		PHASES: 3		WIRE: 4		MAIN CAPACITY: 225 A				
		A/C RATING:		LOCATION:		ELEC EC2D		MAIN CONNECTION:				
		MOUNTING:		SURFACE		FEEDER SIZE:		SEE ELECTRICAL ONE-LINE DIAGRAM				
CKT	ITEM FED	WIRE SIZE	AMPS	POLES	A (WATTS)	B (WATTS)	C (WATTS)	POLES	AMPS	WIRE SIZE	ITEM FED	CKT
1	DAYROOM LIGHTS	-	20 A	1	0 0 0				1	20 A	WARD, ISOLATION LIGHTS	2
3	HEAD NURSE LIGHTS	-	20 A	1		0 0 0		1	20 A	-	WARD LIGHTS	4
5	STAFF LOUNGE LIGHTS	-	20 A	1			0 0 0	1	20 A	-	WARD LIGHTS	6
7	PHYS. EXAM. LIGHTS	-	20 A	1	0 0 0			1	20 A	-	HEADWALL 246, 249, 250 LTS.	8
9	HEADWALL 251, 252, 253 LTS.	-	20 A	1		0 0 0		1	20 A	-	HEADWALL 246, 249, 250 REC.	10
11	HEADWALL 251, 252, 253 BED	-	20 A	1			0 0 0	1	20 A	-	HEADWALL 246, 249, 250 BED	12
13	HEADWALL 251, 252, 253 REC.	-	20 A	1	0 0 0			1	20 A	-	HEADWALL 225, 226, 229 LTS.	14
15	LOCKER/LOUNGE OUTLETS	-	20 A	1		0 0 0		1	20 A	-	HEADWALL 225, 226, 229 BED	16
17	PHYSICIAN EXAM. OUTLETS	-	20 A	1			0 0 0	1	20 A	-	HEADWALL 225, 226, 229 REC.	18
19	LOUNGE REFRIG.	-	20 A	1	0 0 0			1	20 A	-	NURSE CLINIC, OUTLETS	20
21	PHYSICIAN EXAM. OUTLETS	-	20 A	1		0 0 0		1	20 A	-	HEAD NURSE OUTLETS	22
23	PHYS. ASST. EXAM OUTLETS	-	20 A	1			0 0 0	1	20 A	-	SOCIAL WORKER OUTLETS	24
25	RM 262A+ WATER COOL	-	20 A	1	0 0 0			1	20 A	-	WARD 253, 254 OUTLETS	26
27	RM 262A+ WARD	-	20 A	1		0 0 0		1	20 A	-	WARD 225, 226 OUTLETS	28
29	RM 262	-	20 A	1			0 0 0	1	20 A	-	SOILED UTIL. OUTLETS	30
31	STERILE SUPPLY OUTLETS	-	20 A	1	0 0 0			1	20 A	-	BEDPAN STERILIZER	32
33	RESPIRATORY THERAPY OUTLETS	-	20 A	1		0 0 0		1	20 A	-	ISOLATION 249 OUTLETS	34
35	WARD 252, 253 OUTLETS	-	20 A	1			0 0 0	1	20 A	-	WARD 250, 251 OUTLETS	36
37	EF-2 AND EF-3	-	20 A	1	0 0 0			1	20 A	-	SPARE	38
39	EF-1	-	20 A	1		0 0 0		1	20 A	-	SPARE	40
41	262 H.WALL CONVENIENCE...	-	20 A	1			0 0 0	1	20 A	-	HEADWALL BED 262	42
TOTAL CONNECTED LOAD:					0 W	0 W	0 W	AMPS: 0 A	LOAD: 0 W			

CCT		VOLTS: 120/208 Wye				PHASES: 3		WIRE: 4				MAIN CAPACITY: 225 A	
		AIRC RATING: 22K		LOCATION:		ELEC EC2B				MAIN CONNECTION: MLO			
		MOUNTING:		SURFACE		SEE ELECTRICAL ONE-LINE DIAGRAM				MAIN TYPE: TYPE 1			
CRK	ITEM FED	WIRE SIZE	AMPS	POLES	A (WATTS)	B (WATTS)	C (WATTS)	POLES	AMPS	WIRE SIZE	ITEM FED	CRK	
1	RMS 205,205C,206,206B RECEPTS	12	20 A	1	720	1320						2	
3	RM 205 HEAD WALL UNIT...	12	20 A	1		720	1320		3	20 A	12	EF-8A	
5	RM 206 HEAD WALL UNIT...	12	20 A	1			720	1320				4	
7	RMS 207,207B,208,208C RECEPTS	12	20 A	1	720	900			1	20 A	12	FC-1	
9	RM 207 HEAD WALL UNIT ...	12	20 A	1		720	1000		1	20 A	12	C-CURVE 9000	
11	RM 208 HEAD WALL UNIT ...	12	20 A	1			720	600	1	20 A	12	MED. GAS PNL., FAUCET TR.	
13	RM 208C REF. RECEPT	12	20 A	1	600	500			1	20 A	12	WONDER MANAGEMENT	
15	R208C OMMI CELL RECEPT	12	20 A	1		1200	0		--	--		SPACE	
17	RM 274 HEAD WALL UNIT...	12	20 A	1			720	720	1	20 A	12	CAMERA CEILING REC'S.	
19	RMS 274, 274B RECEPTS	12	20 A	1	540	0			--	--		SPACE	
21	RM 250 RECEPTS	12	20 A	1		540	0		--	--		SPACE	
23							1000	0	--	--		SPACE	
25	RM 250 DATA RACK REC.	12	30 A	3	1000	0			--	--		SPACE	
27						1000	0		--	--		SPACE	
29							1000	0		--		SPACE	
31	RM 250 DATA RACK REC.	12	30 A	3	1000	0			2	20 A	12	NURSE CALL P.S.	
33							1000	0	1	20 A	12	INTERCOM P.S.	
35								1000	0	1	20 A	12	NURSE STA CTR CNSL REC
37	RM 252 DATA RACK REC.	12	30 A	3	1000	0							
39						1000	0		3	100 A		PANEL 25C1 (NOTE 1)	
41								1000	0				
43	RM 252 DATA RACK REC.	12	30 A	3	1000	0							
45							1000	0	3	100 A		PANEL 25C1 (NOTE 1)	
47	RM 252 RECEPTS	12	20 A	1				540	0				
49	PATIENT RMS & RM 204,250,252...	12	20 A	1	1440	0							
51	RM 204 RECEPTS	12	20 A	1			360	0					
53	PAT TLT 205A-208A LTG (NOTE 2)	12	20 A	1				270	0				
TOTAL CONNECTED LOAD:					10740 W	9860 W	9610 W	AMPS:	84 A	LOAD:	30210 W		

NOTES:
1. REFER TO ELECTRICAL ONE-LINE DIAGRAM FOR WIRE SIZE.
2. PROVIDE GFI BREAKER.

2CLS		VOLTS: 120/208 Wye		PHASES: 3		WIRE: 4		MAIN CAPACITY: 225 A						
		AIC RATING: 22K		LOCATION: STAIR B ST2B		MLO		225 A						
		MOUNTING: SURFACE		FEEDER SIZE: SEE ELECTRICAL ONE-LINE DIAGRAM		MAIN CONNECTION: MLO		TYPE 1						
OKT	ITEM FED	WIRE SIZE	AMPS	POLES	A (WATTS)	B (WATTS)	C (WATTS)	POLES	AMPS	WIRE SIZE	ITEM FED	OKT		
1	CORR. C200 DOOR HOLDS	12	20 A	1	1800	500			1	20 A	12	RM. 204 MEDICAL GAS ALARMS	2	
3	CORR. C201 LIGHTING	12	20 A	1			248	500		1	20 A	12	RM. 234 MEDICAL GAS ALARMS	4
5	CORR. 200, 200B LIGHTING	12	20 A	1			433	800	1	20 A	12	ISOLATION PRESSURE SENSORS	6	
7	CORR. C200D-C 200F LIGHTING	12	20 A	1	389	600			1	20 A	12	ISOLATION PRESSURE SENSORS	8	
9	CORR C200F DOOR ACTUATOR	12	20 A	1		480	0		--	--	--	SPACE	10	
11	RM. 265 MEDICAL GAS ALARMS	12	20 A	1			500	0	--	--	--	SPACE	12	
TOTAL CONNECTED LOAD:					3289 W		1228 W		1733 W	AMPS: 17 A	LOAD: 6250 W			

[illegible]

CONSULTANTS

STRUCTURAL

Albertson Eng
Albertson Eng
3202 W. Main S
Rapid City, Sou
Phone: 605-343

**MECHANICAL / ELECTRICAL /
PLUMBING:**

WPE WEST PLAINS
ENGINEERING, INC.


West Plains Engineering, Inc.
1750 Rand Road
Rapid City, South Dakota 57702
Phone: 605-348-7455

ARCHITECT OF RECORD

A/E:
STONE GROUP ARCHITECTS, INC
319 N. MAIN AVE.
SIoux FALLS, SD 57104
605.271.1144
TODD STONE, AIA



STAMI

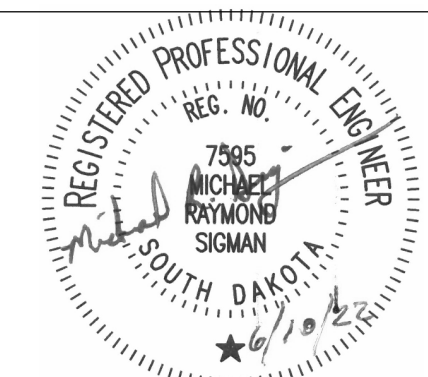

Office of
Construction
and Facilities
Management



U.S. Department
of Veterans Affairs

Drawing Title	ELECTRICAL SCHEDULES
---------------	----------------------

Approved:

Phase	BID DOCUMENTS
-------	---------------

FULLY SPRINKLERED

Project Title	RENOVATE AND CONSOLIDATE INPATIENT FUNCTIONS
---------------	---

Location	FORT MEADE, SOUTH DAKOTA
----------	--------------------------

Checked	D
MBS	

Project Number VA #568-14-110 WPE #BR21020
Building Number 113


Drawing Number

EJ103

three inches = one foot
one and one half inches = one foot
one inch = one foot
three quarters inch = one foot
one half inch = one foot
three eighths inch = one foot
one quarter inch = one foot
one eighth inch = one foot

6/10/2022 8:16:32 AM
C:\Revit\Local Files\2020\06\21\020-RENOVATE AND CONSOLIDATE INFANT FUNCTIONS BUILDING 1154\MEP\20-CENTRAL_McReggie.rvt


1 SECOND FLOOR FIRE PROTECTION PLAN
1/16" = 1'-0"

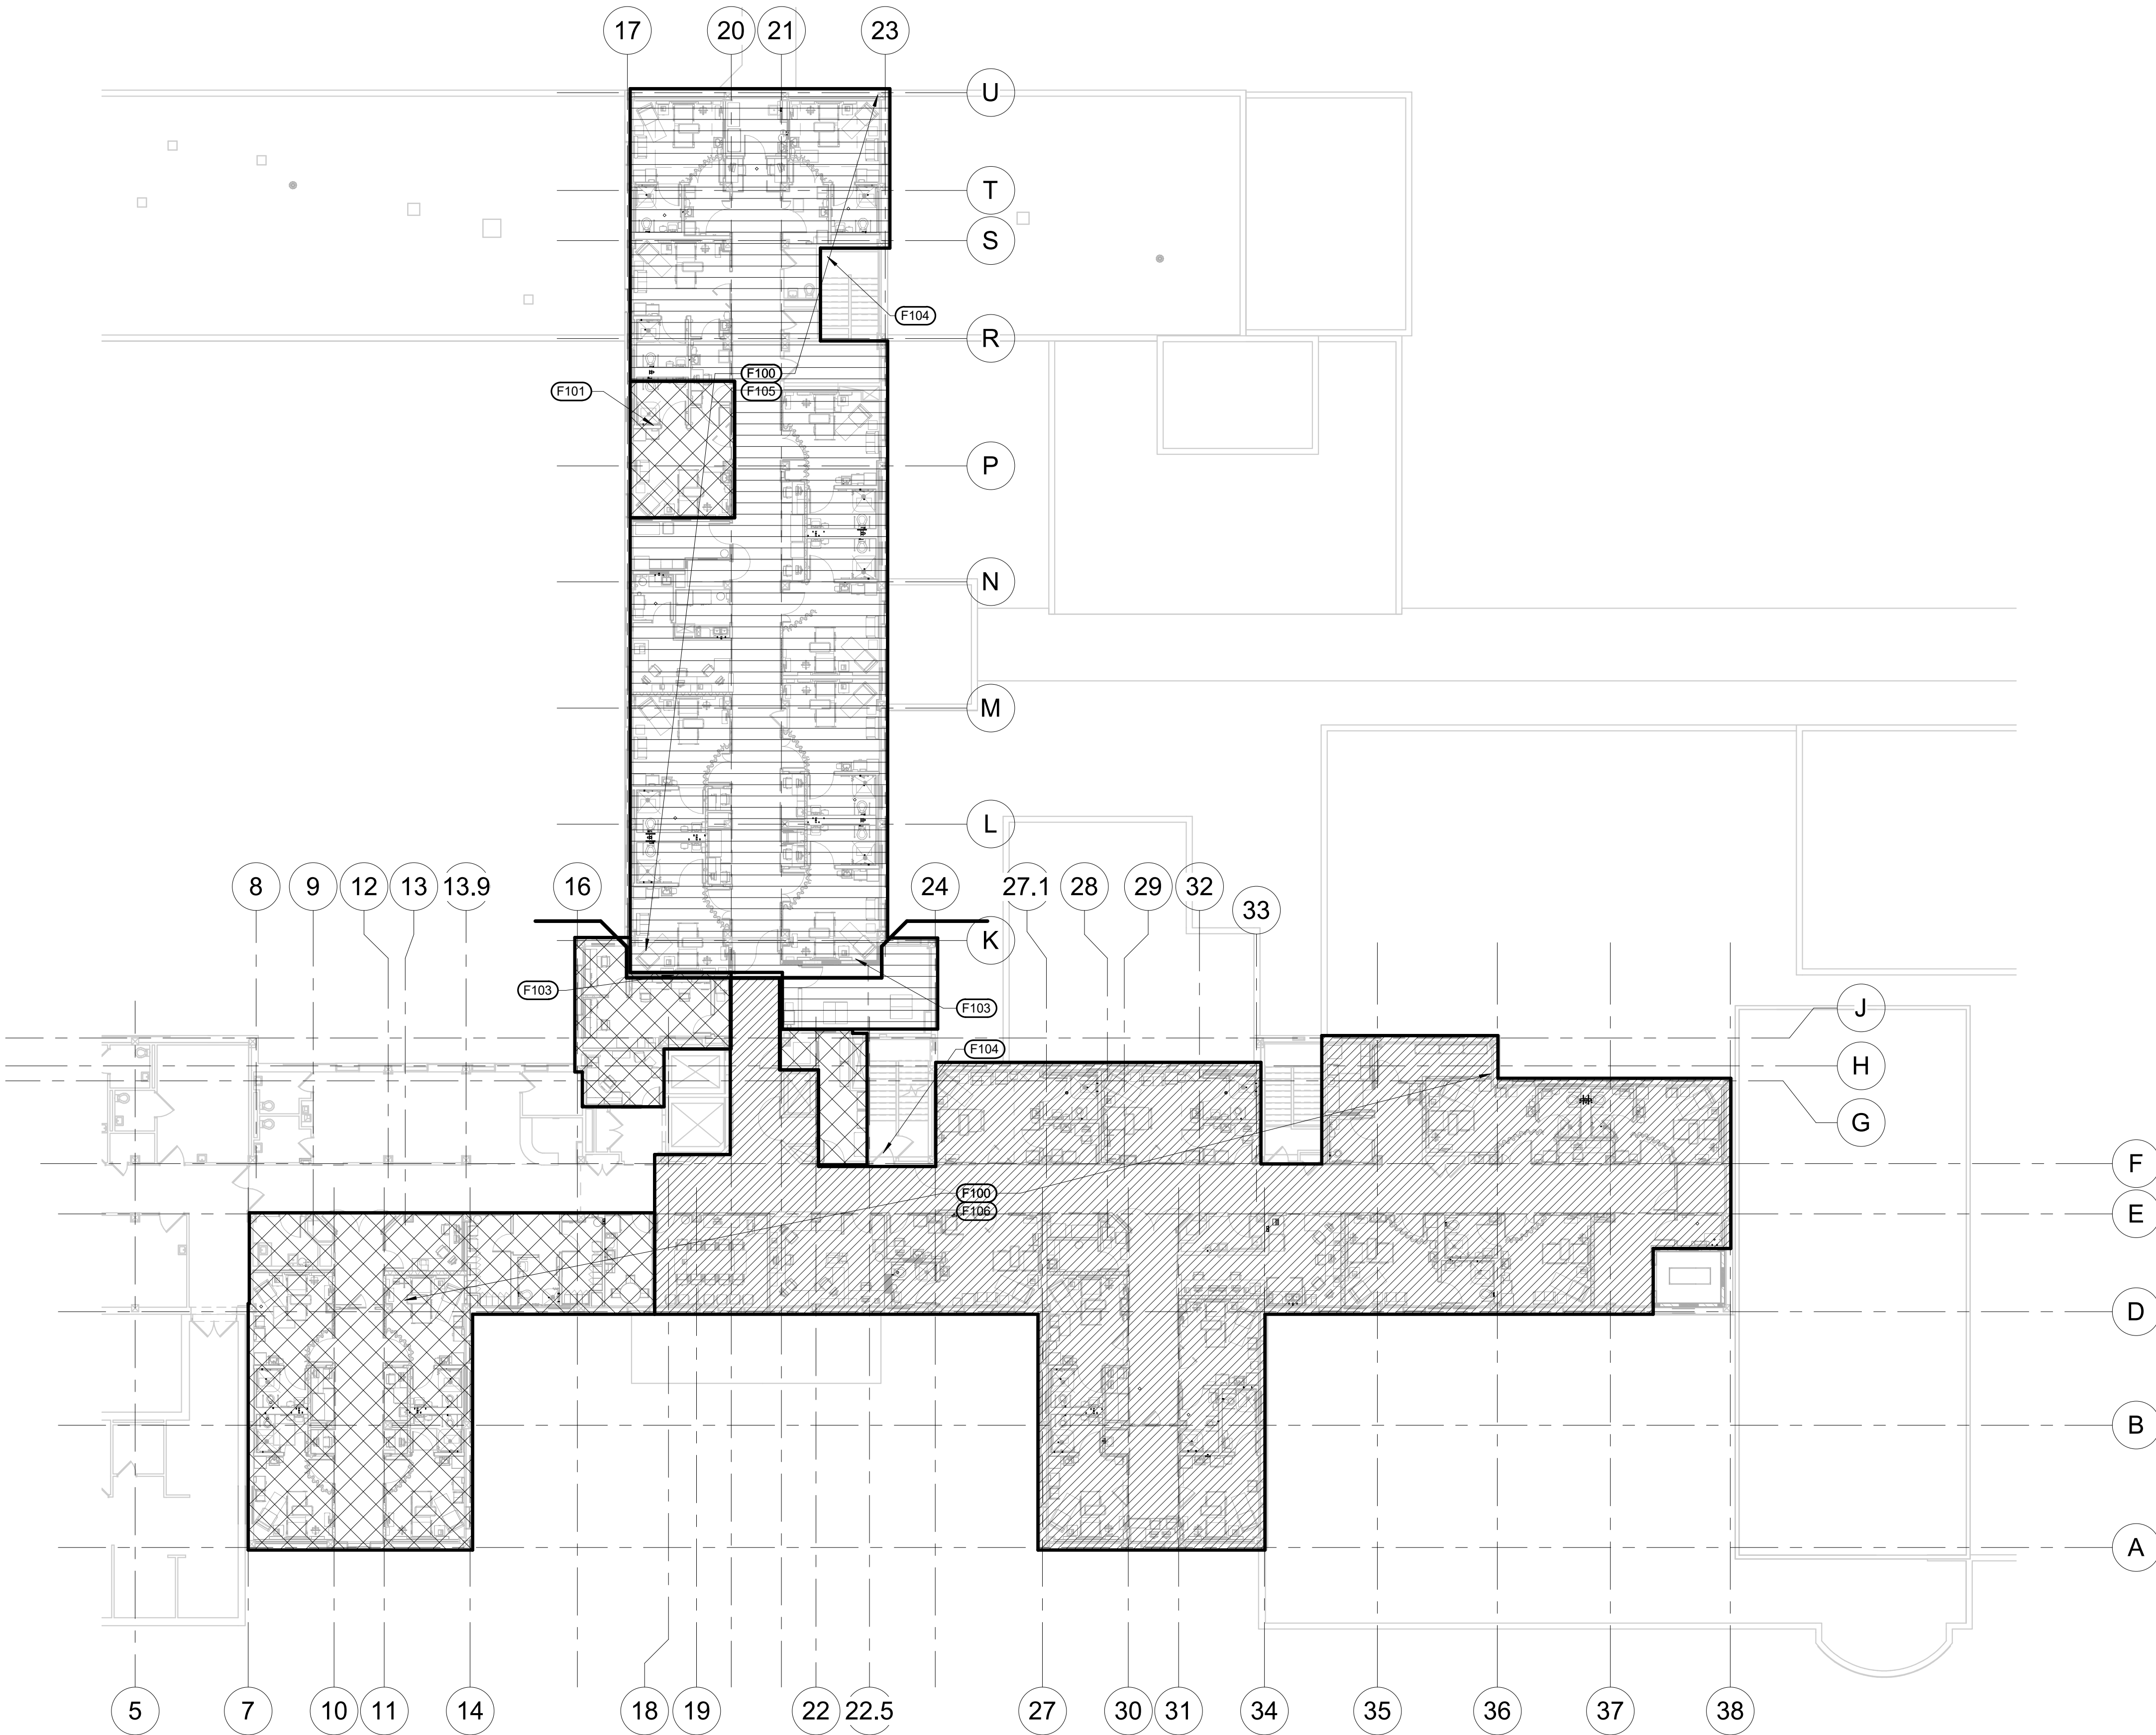

- FIRE PROTECTION HAZARD CLASSIFICATION**
- A LIGHT HAZARD OCCUPANCIES: PATIENT CARE, TREATMENT, AND CUSTOMARY ACCESS AREAS.
 - B ORDINARY HAZARD GROUP 1 OCCUPANCIES: MECHANICAL EQUIPMENT ROOMS, TRANSFORMER ROOMS, ELECTRICAL SWITCHGEAR ROOMS, AND ELECTRIC CLOSETS.
 - C ORDINARY HAZARD GROUP 2 OCCUPANCIES: STORAGE ROOMS, TRASH ROOMS, CLEAN AND SOILED LINEN ROOMS, PHARMACY AND ASSOCIATED STORAGE, LAUNDRY, STORAGE, STORAGE AREAS FOR THE ENTIRE AREA OF THE SPACE UP TO 140 SQUARE METERS (1500 SQUARE FEET).

- GENERAL FIRE PROTECTION NOTES**
- A COORDINATE LOCATION OF PIPING, PIPING ACCESSORIES, ETC., WITH ARCHITECTURAL CEILING GRID. REFER TO REFLECTED CEILING PLAN FOR CEILING LOCATIONS.
 - B ENTIRE BUILDING SHALL BE PROTECTED BY A WET FIRE SPRINKLER SYSTEM IN ACCORDANCE WITH THE REQUIREMENTS OF NFPA 13 AND THE AUTHORITY HAVING JURISDICTION.
 - C STATIC PRESSURE ON LOWER LEVEL (APPROXIMATELY 20 FT FROM FIRE SERVICE CONNECTION) IS ESTIMATED TO BE 65 PSI WITH A RESIDUAL PRESSURE FLOW ESTIMATED AT 50 PSI/1400 GPM. SIZE FIRE SPRINKLER PIPING TO PROVIDE A MINIMUM OF 10% FACTOR OF SAFETY FOR SYSTEM PRESSURE. CONTRACTOR TO CONFIRM ACTUAL SYSTEM FLOW/PRESSURE PRIOR TO HYDRAULIC CALCULATIONS.
 - D SPACE ABOVE CEILING IS LIMITED. CONTRACTOR SHALL COORDINATE ALL PIPE ROUTING WITH ALL OTHER TRADES. PROVIDE ALL ADDITIONAL OFFSETS AND TRANSITIONS AS REQUIRED TO COMPLETE INSTALLATION.
 - E BUILDING OCCUPANCY/COMMODITY CLASSIFICATION IS LIGHT HAZARD FOR PATIENT ROOMS, CORRIDORS, NURSES STATIONS, ETC. STORAGE ROOMS SHALL BE ORDINARY HAZARD GROUP 2. ALL FIRE SPRINKLER PROTECTION OF BUILDING SHALL BE CONSIDERED AS SUCH. REFER TO ARCHITECTURAL AND STRUCTURAL PLANS FOR BUILDING CONSTRUCTION TYPE, OCCUPANCY, BUILDING CROSS SECTIONS, AND CEILING LAYOUT.
 - F FOLLOWING COMPLETION OF CONSTRUCTION, THE FIRE SPRINKLER CONTRACTOR SHALL PROVIDE A WRITTEN LETTER INDICATING SYSTEM HAS BEEN INSTALLED AND TESTED IN ACCORDANCE WITH THE MANUFACTURER'S RECOMMENDATIONS AND THE APPROPRIATE NATIONAL FIRE PROTECTION ASSOCIATION (NFPA) REQUIREMENTS. ALSO INCLUDE A COPY OF THE INSPECTION REPORT FROM THE AUTHORITY HAVING JURISDICTION.
 - G FIRE SPRINKLER PIPING MAINS SHOWN FOR INTENDED ROUTING. CONTRACTOR TO FOLLOW FIRE SPRINKLER ROUTING FOR HYDRAULIC CALCULATIONS AND SYSTEM INSTALLATION.
 - H HATCHING STYLE DENOTES DIFFERENT PROJECT PHASES. REFER TO ARCHITECTURAL PLANS FOR DESCRIPTION OF PHASES. SPRINKLER SYSTEMS SERVING OCCUPIED AREAS SHALL REMAIN OPERATIONAL AT ALL TIMES.
 - I PROVIDE TEMPORARY UPRIGHT SPRINKLERS IN CONSTRUCTION AREAS WHERE CONTRACTOR CHOOSES THE OPTION IDENTIFIED ON SHEET G1102. THE TEMPORARY SPRINKLERS SHALL REMAIN OPERATIONAL UNTIL THE NEW SPRINKLERS ARE INSTALLED AND OPERATIONAL.

- MECHANICAL SPECIFIC NOTES**
- F100 REMOVE AND REPLACE EXISTING FIRE PROTECTION PIPING WITHIN THIS AREA.
 - F101 WORK WITHIN THIS ROOM IS TO BE COMPLETED AS PART OF PHASE 1.
 - F102 FIRE PROTECTION IN THE ELEVATOR SHAFT INCLUDES PROTECTION OF THE ELEVATOR PIT.
 - F103 FIRE SMOKE BARRIER. PROVIDE SEPARATE SPRINKLER ZONES FOR SEPARATE FIRE/SMOKE ZONES.
 - F104 FIRE SPRINKLER ZONE CONTROL ASSEMBLY WITHIN THIS AREA.
 - F105 FIRE SPRINKLER ZONE B/C
 - F106 FIRE SPRINKLER ZONE A
 - F200 REMOVE AND REPLACE EXISTING FIRE PROTECTION PIPING WITHIN THIS AREA.
 - F201 PROVIDE FLOW SWITCH ON FIRE SPRINKLER PIPING SERVING ELEVATOR MACHINE ROOM AND THE BOTTOM OF THE ELEVATOR SHAFT FOR CONNECTION TO SHUNT TRIP BREAKER PROVIDED BY THE ELECTRICAL CONTRACTOR.

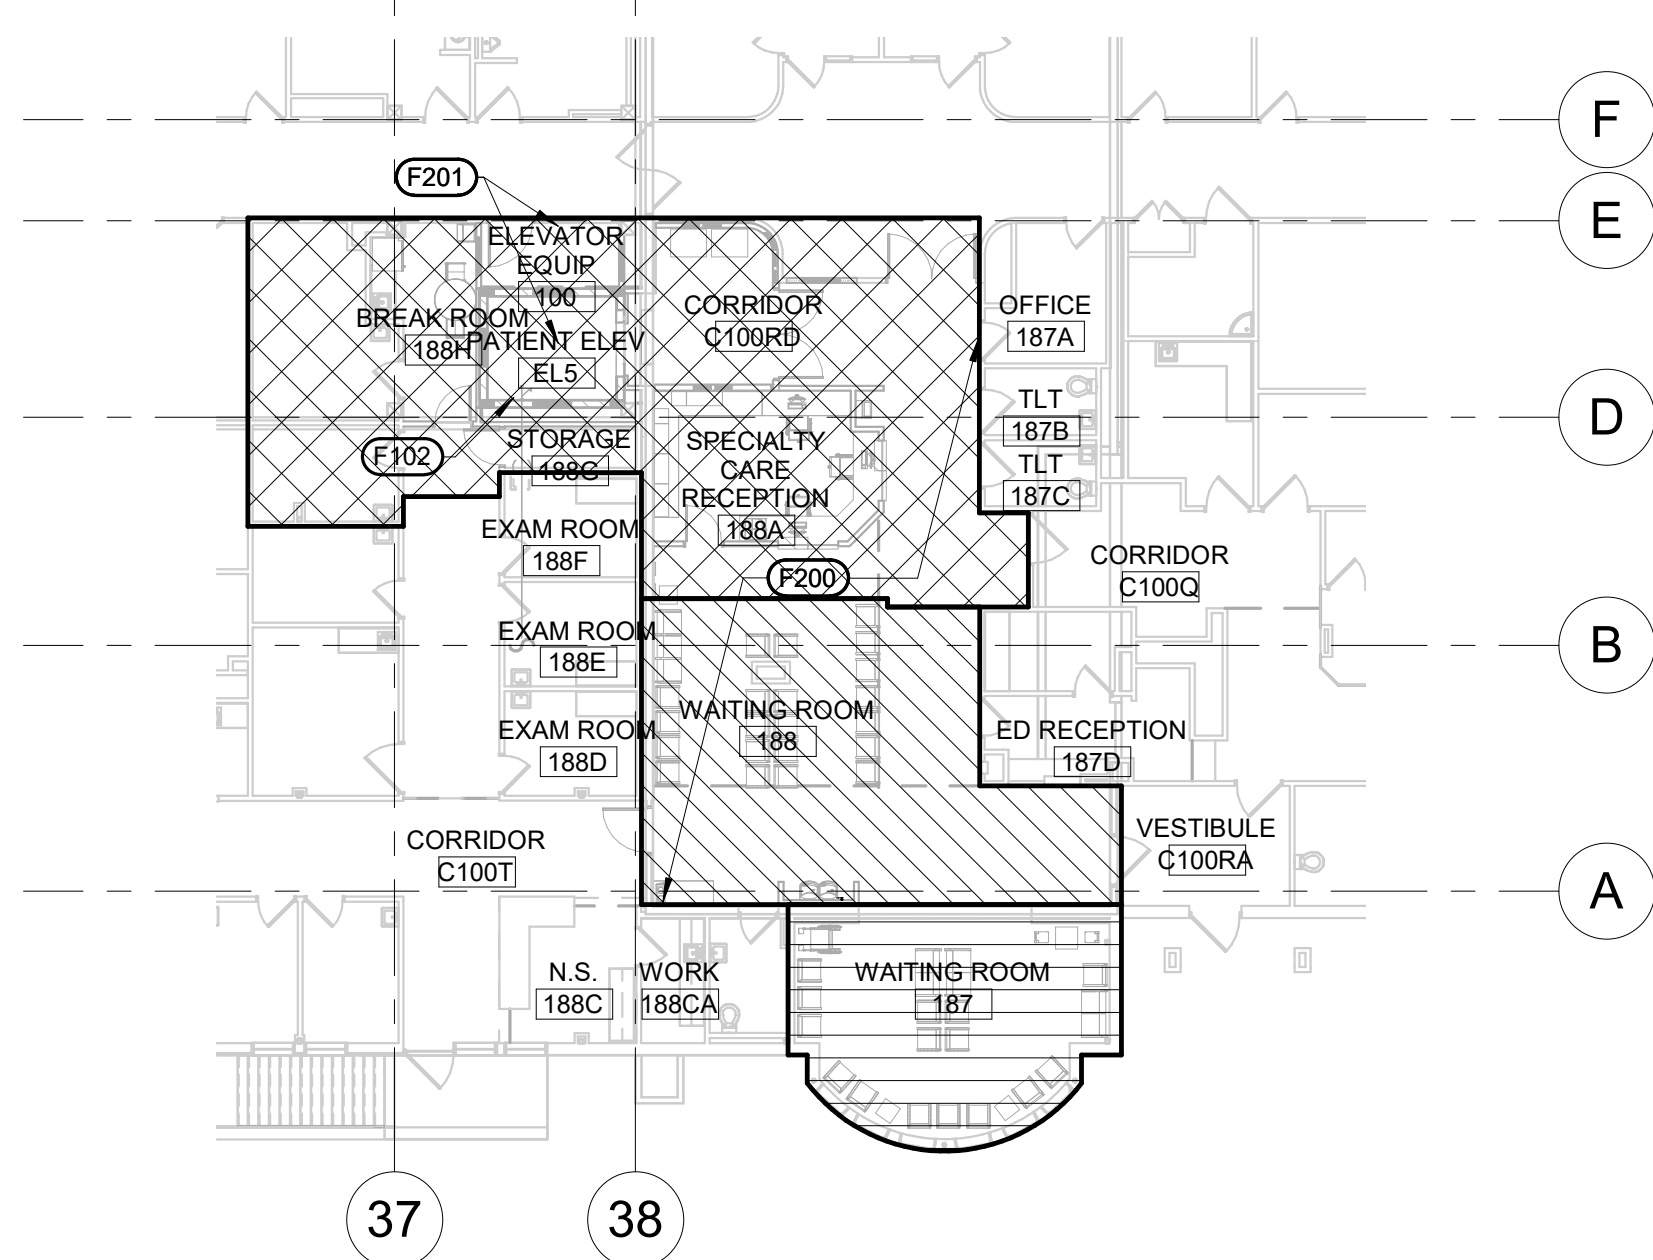

2 FIRST FLOOR AREA C FIRE PROTECTION PLAN
1/16" = 1'-0"

Revision#	Description	Date:

CONSULTANTS

STRUCTURAL:
Albertson Engineering, Inc.
3302 W. Main St. #C
Rapid City, South Dakota 57702
Phone: 605-343-9606

MECHANICAL / ELECTRICAL / PLUMBING:
WPE WEST PLAINS ENGINEERING, INC.
1750 Rand Road
Rapid City, South Dakota 57702
Phone: 605-348-7455

ARCHITECT OF RECORD

A/E:
STONE GROUP ARCHITECTS, INC.
319 N. MAIN AVE.
SIOUX FALLS, SD 57104
605.271.1144
TODD STONE, AIA



STAMP



Office of
Construction
and Facilities
Management



U.S. Department
of Veterans Affairs

Drawing Title
FIRE PROTECTION

Approved:

Phase
CONSTRUCTION DOCUMENTS

FULLY SPRINKLERED

Project Title
RENOVATE AND CONSOLIDATE
INFANT FUNCTIONS

Location
FORT MEADE, SOUTH DAKOTA

Issue Date
06/10/2022

Checked
MSH


Drawn
MMM

Project Number
VA #568-14-110
WPE #BR21020
Building Number
113


Drawing Number
FX101

one eighth inch = one foot
one quarter inch = one foot
three eighths inch = one foot
one half inch = one foot
one inch = one foot
three quarters inch = one foot
one and one half inches = one foot
three inches = one foot

C:\Revit\Local Files\2020\08\21\020-RENOVATE AND CONSOLIDATE INPATIENT FUNCTIONS BUILDING 113\MEP20-CENTRAL_McReggie.rvt 6/10/2022 8:16:35 AM

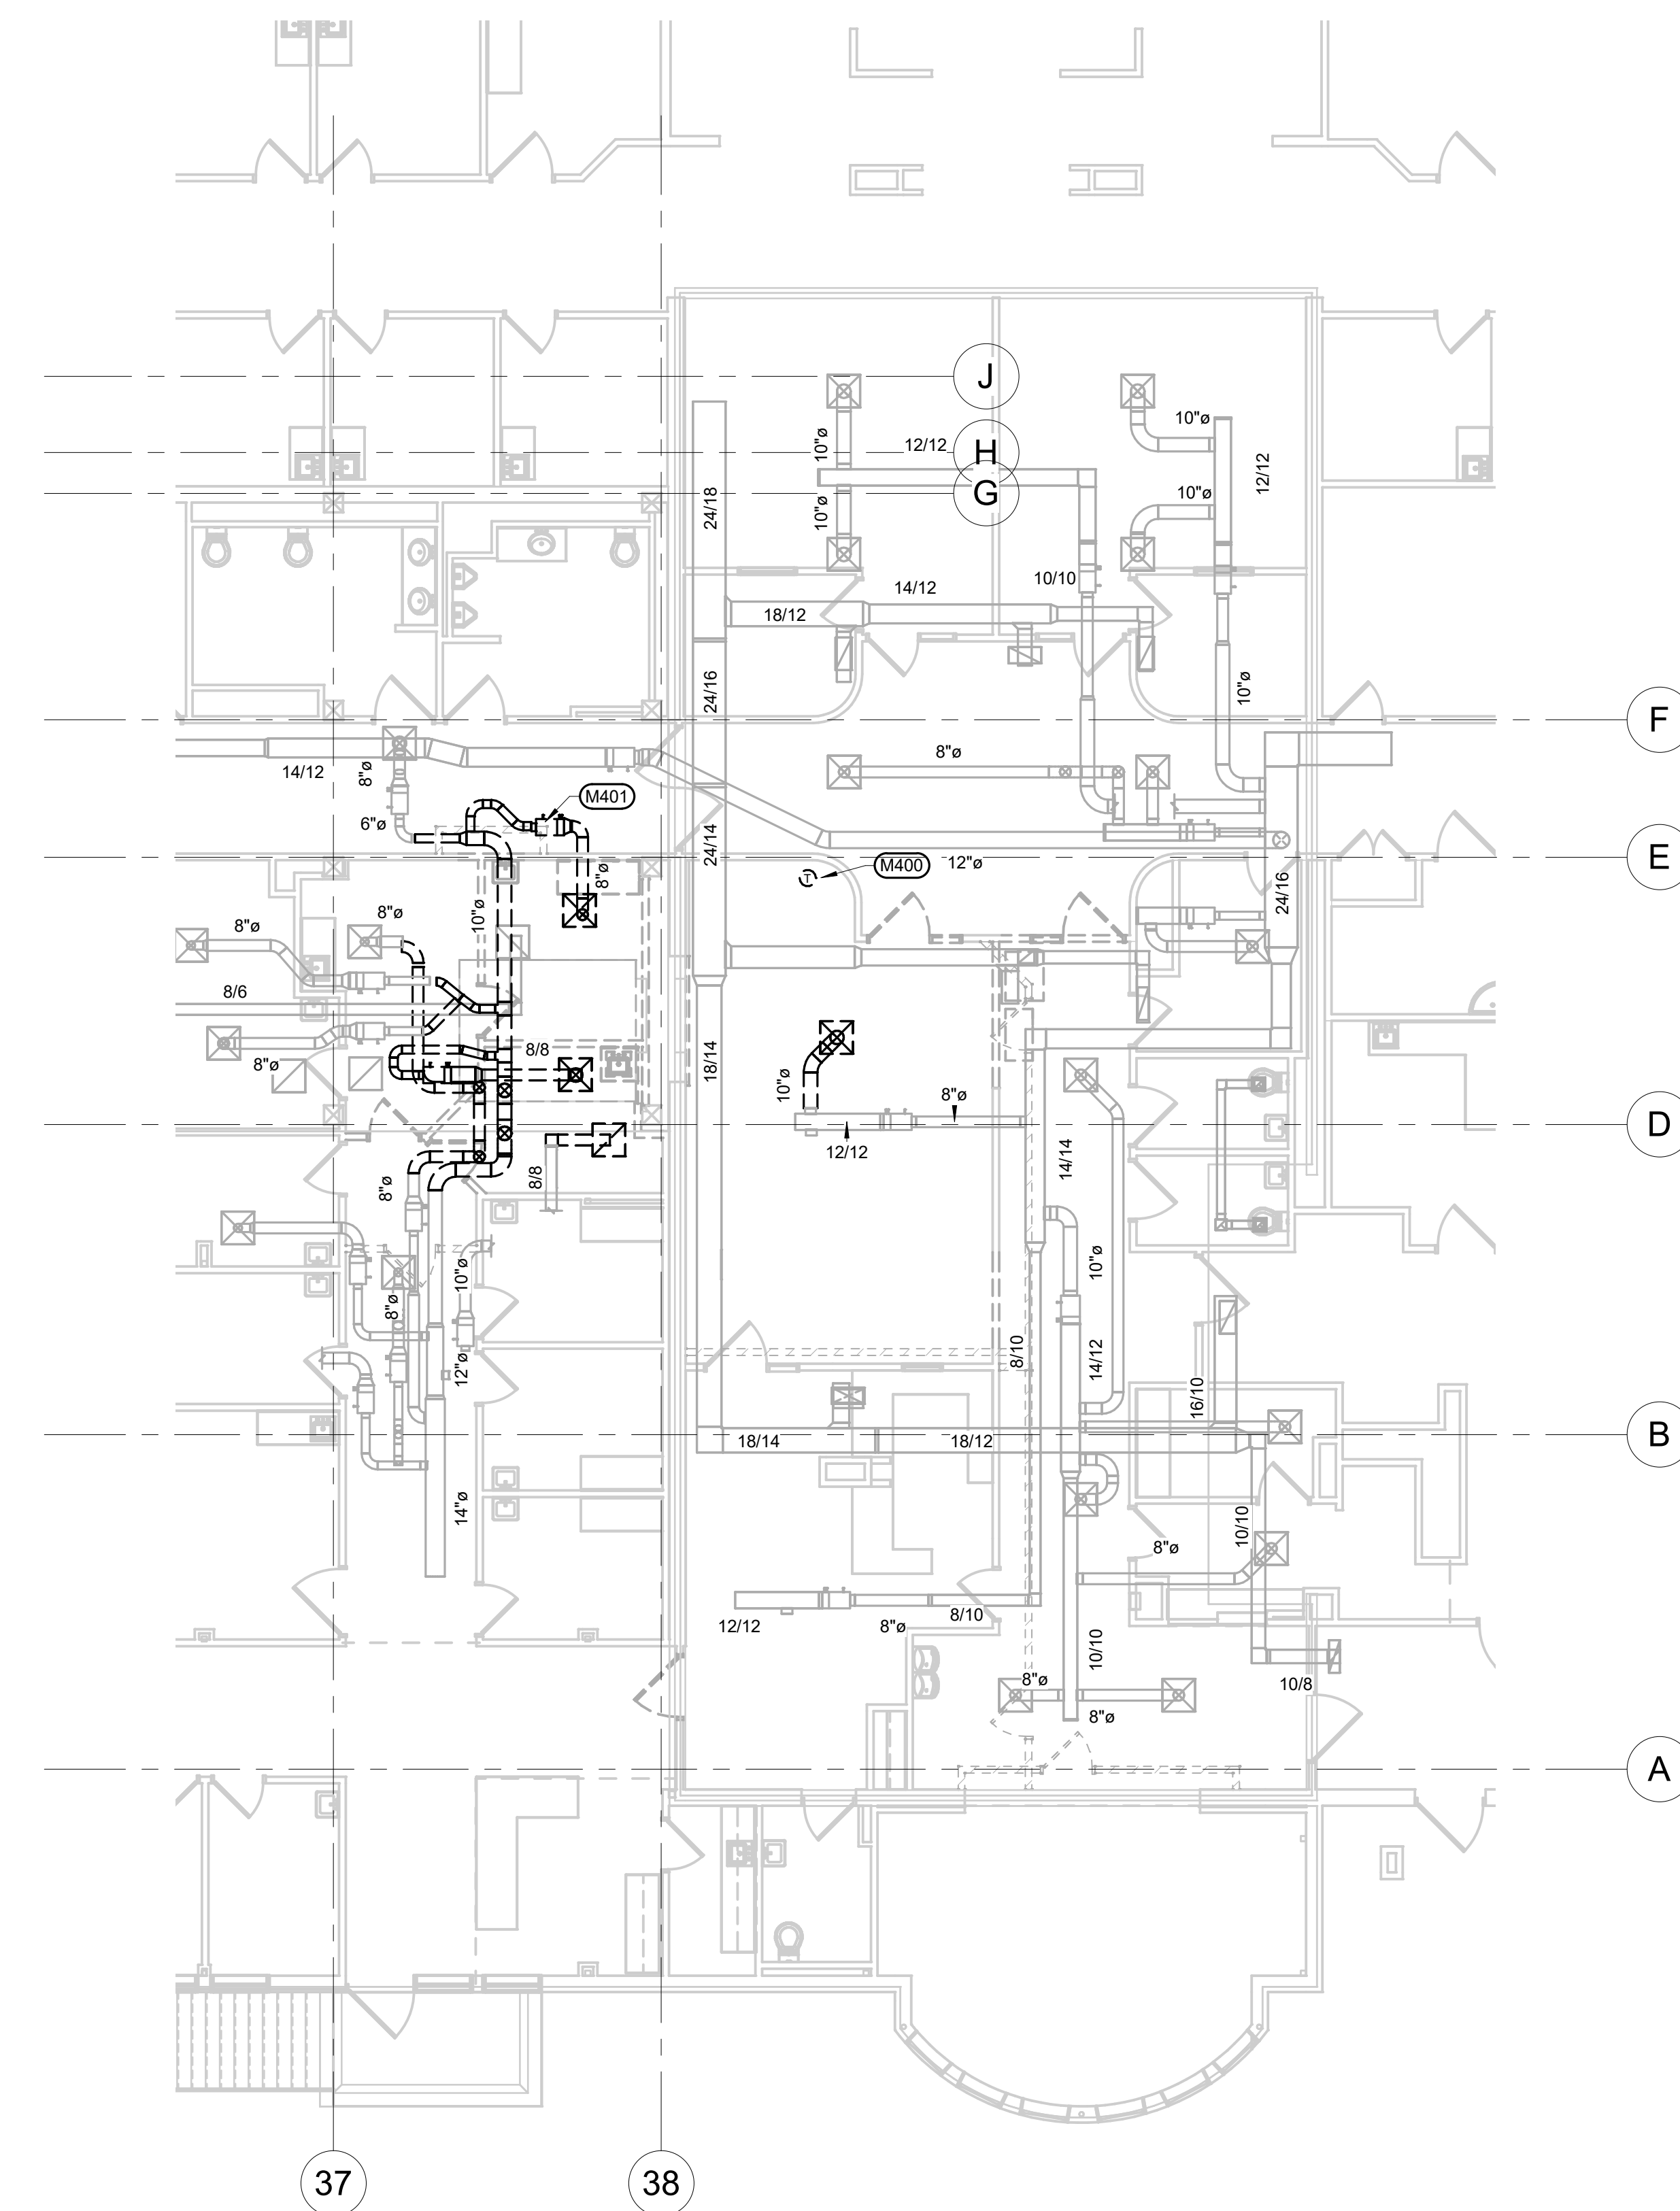

2 FIRST FLOOR AREA C HVAC DEMOLITION PLAN ALT# 4
1/8" = 1'-0"

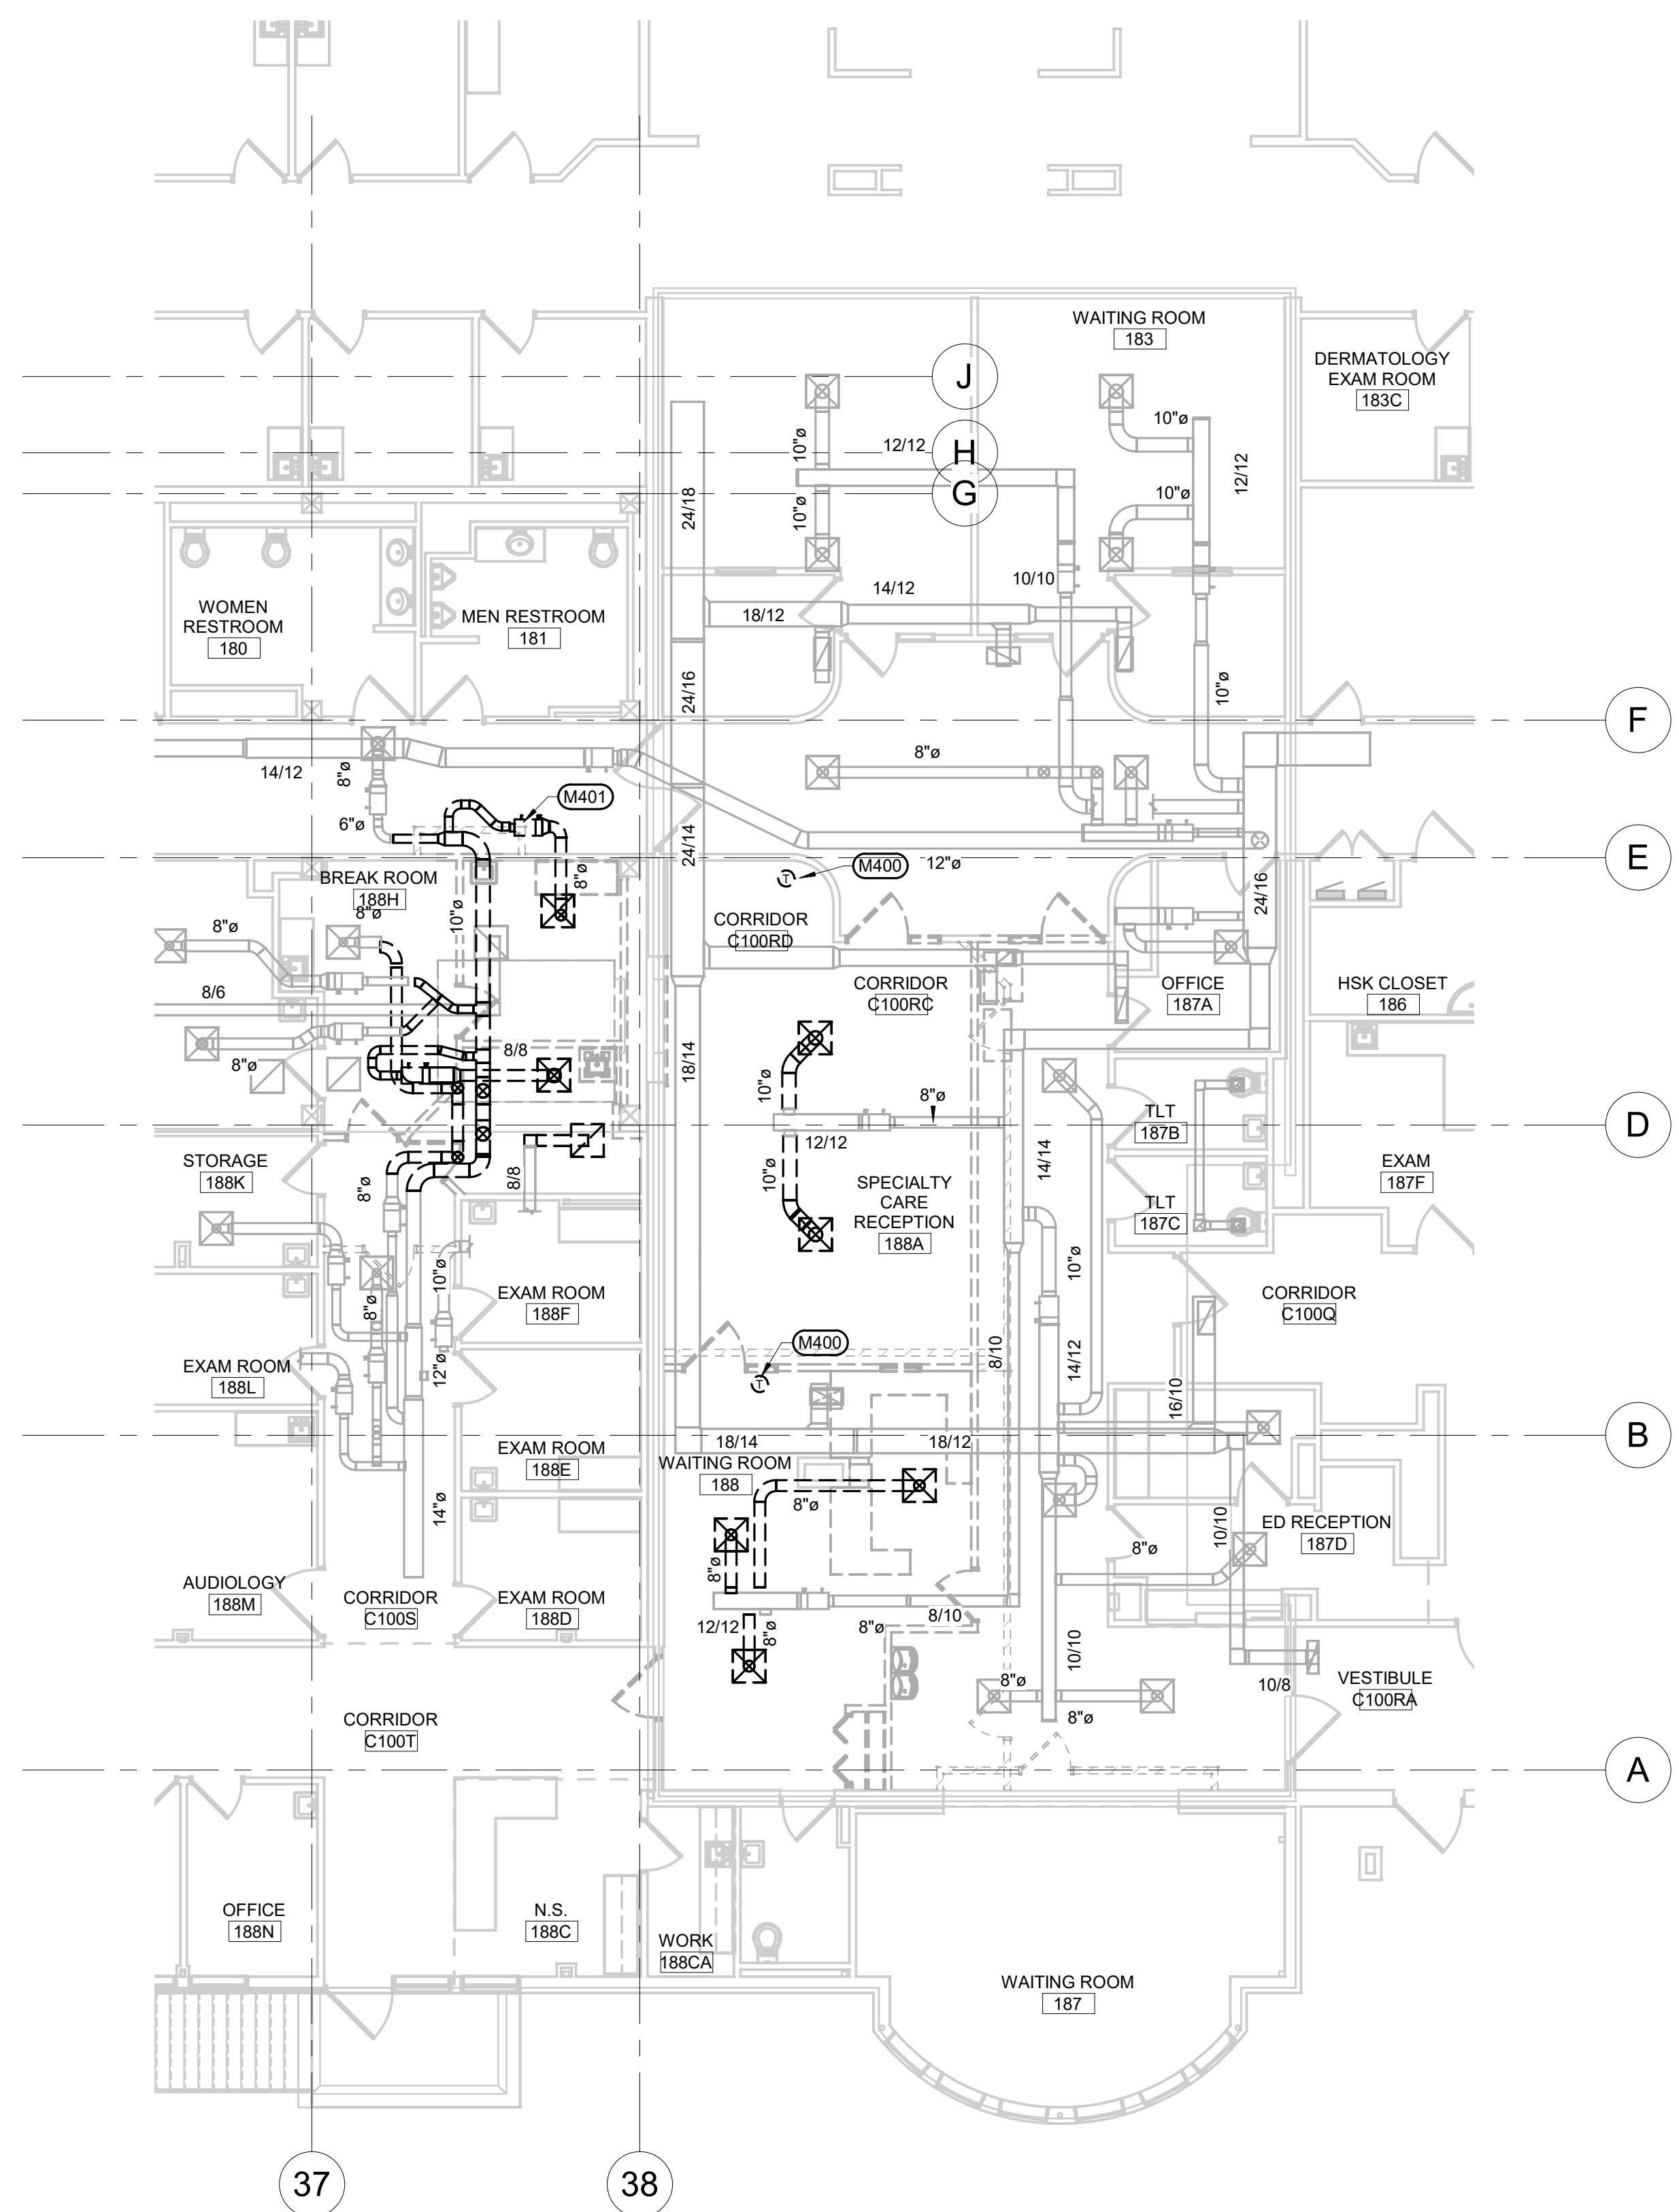

1 FIRST FLOOR AREA C HVAC DEMOLITION PLAN
1/8" = 1'-0"

- GENERAL MECHANICAL NOTES**
- A. COORDINATE PHASING AND REMOVAL OF EXISTING DUCTWORK AND EQUIPMENT WITH CONTRACTING OFFICER.
 - B. REMOVE EXISTING DUCTWORK, EQUIPMENT, ETC. WHERE DASHED. CAP DUCTWORK DURING CONSTRUCTION.
 - C. CONTRACTOR TO CONFIRM LOCATIONS OF EXISTING DUCTWORK AND EQUIPMENT.

- MECHANICAL SPECIFIC NOTES**
- M400 REMOVE EXISTING THERMOSTAT AND ASSOCIATED WIRING/PIPING.
 - M401 REMOVE EXISTING VAV BOX AND ASSOCIATED WIRING/PIPING CONNECTING TO TEMPERATURE CONTROL SYSTEM.

Revision#	Description	Date:

CONSULTANTS

STRUCTURAL:
Albertson Engineering, Inc.
3302 W. Main St. #C
Rapid City, South Dakota 57702
Phone: 605-343-9606


MECHANICAL / ELECTRICAL / PLUMBING:
WPE WEST PLAINS ENGINEERING, INC.
1750 Rand Road
Rapid City, South Dakota 57702
Phone: 605-348-7455

ARCHITECT OF RECORD

A/E:
STONE GROUP ARCHITECTS, INC.
319 N. MAIN AVE.
SIOUX FALLS, SD 57104
605.271.1144
TODD STONE, AIA



STAMP

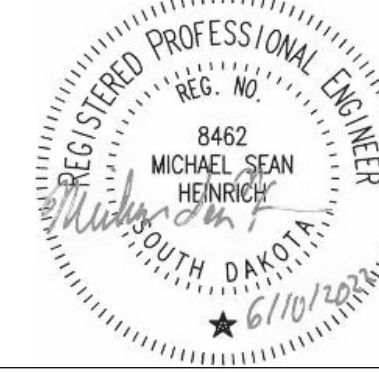

Office of
Construction
and Facilities
Management



U.S. Department
of Veterans Affairs

Drawing Title
FIRST FLOOR AREA C HVAC DEMOLITION
PLAN

Approved:

Phase
CONSTRUCTION DOCUMENTS

FULLY SPRINKLERED

Project Title
RENOVATE AND CONSOLIDATE
INPATIENT FUNCTIONS

Location
FORT MEADE, SOUTH DAKOTA

Issue Date
06/10/2022

Checked
MSH

Drawn
MMM

Project Number
VA #568-14-110
WPE #BR21020
Building Number
113

Drawing Number
MD101

one eighth inch = one foot
one quarter inch = one foot
three eighths inch = one foot
one half inch = one foot
three quarters inch = one foot
one inch = one foot
one and one half inches = one foot
three inches = one foot

C:\Revit\Local Files\2020\B21020-RENOVATE AND CONSOLIDATE INPATIENT FUNCTIONS BUILDING 113\MEP20-CENTRAL_McReggie.rvt 6/10/2022 8:16:40 AM

Revision#	Description	Date:

CONSULTANTS

STRUCTURAL:

Albertson Engineering, Inc.
3302 W. Main St. #C
Rapid City, South Dakota 57702
Phone: 605-343-9606

MECHANICAL / ELECTRICAL / PLUMBING:


West Plains Engineering, Inc.
1750 Rand Road
Rapid City, South Dakota 57702
Phone: 605-348-7455

ARCHITECT OF RECORD

A/E:
STONE GROUP ARCHITECTS, INC.
319 N. MAIN AVE.
SIOUX FALLS, SD 57104
605.271.1144
TODD STONE, AIA



STAMP

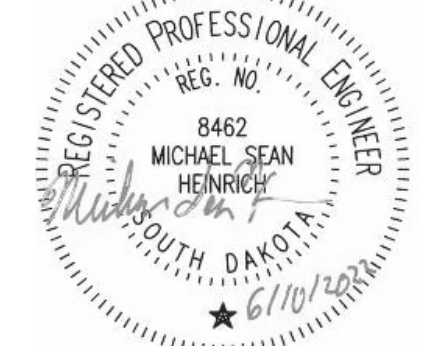

Office of Construction and Facilities Management

 U.S. Department of Veterans Affairs

Drawing Title

SECOND FLOOR AREA B & C HVAC DEMOLITION PLAN

Approved:

Phase

CONSTRUCTION DOCUMENTS

FULLY SPRINKLERED

Project Title

RENOVATE AND CONSOLIDATE INPATIENT FUNCTIONS

Location
FORT MEADE, SOUTH DAKOTA

Issue Date
06/10/2022

Checked
MSH


Drawn
MMM

Project Number
VA #568-14-110
WPE #BR21020

Building Number
113


Drawing Number
MD103

1 SECOND FLOOR AREA B HVAC DEMOLITION PLAN
1/8" = 1'-0"

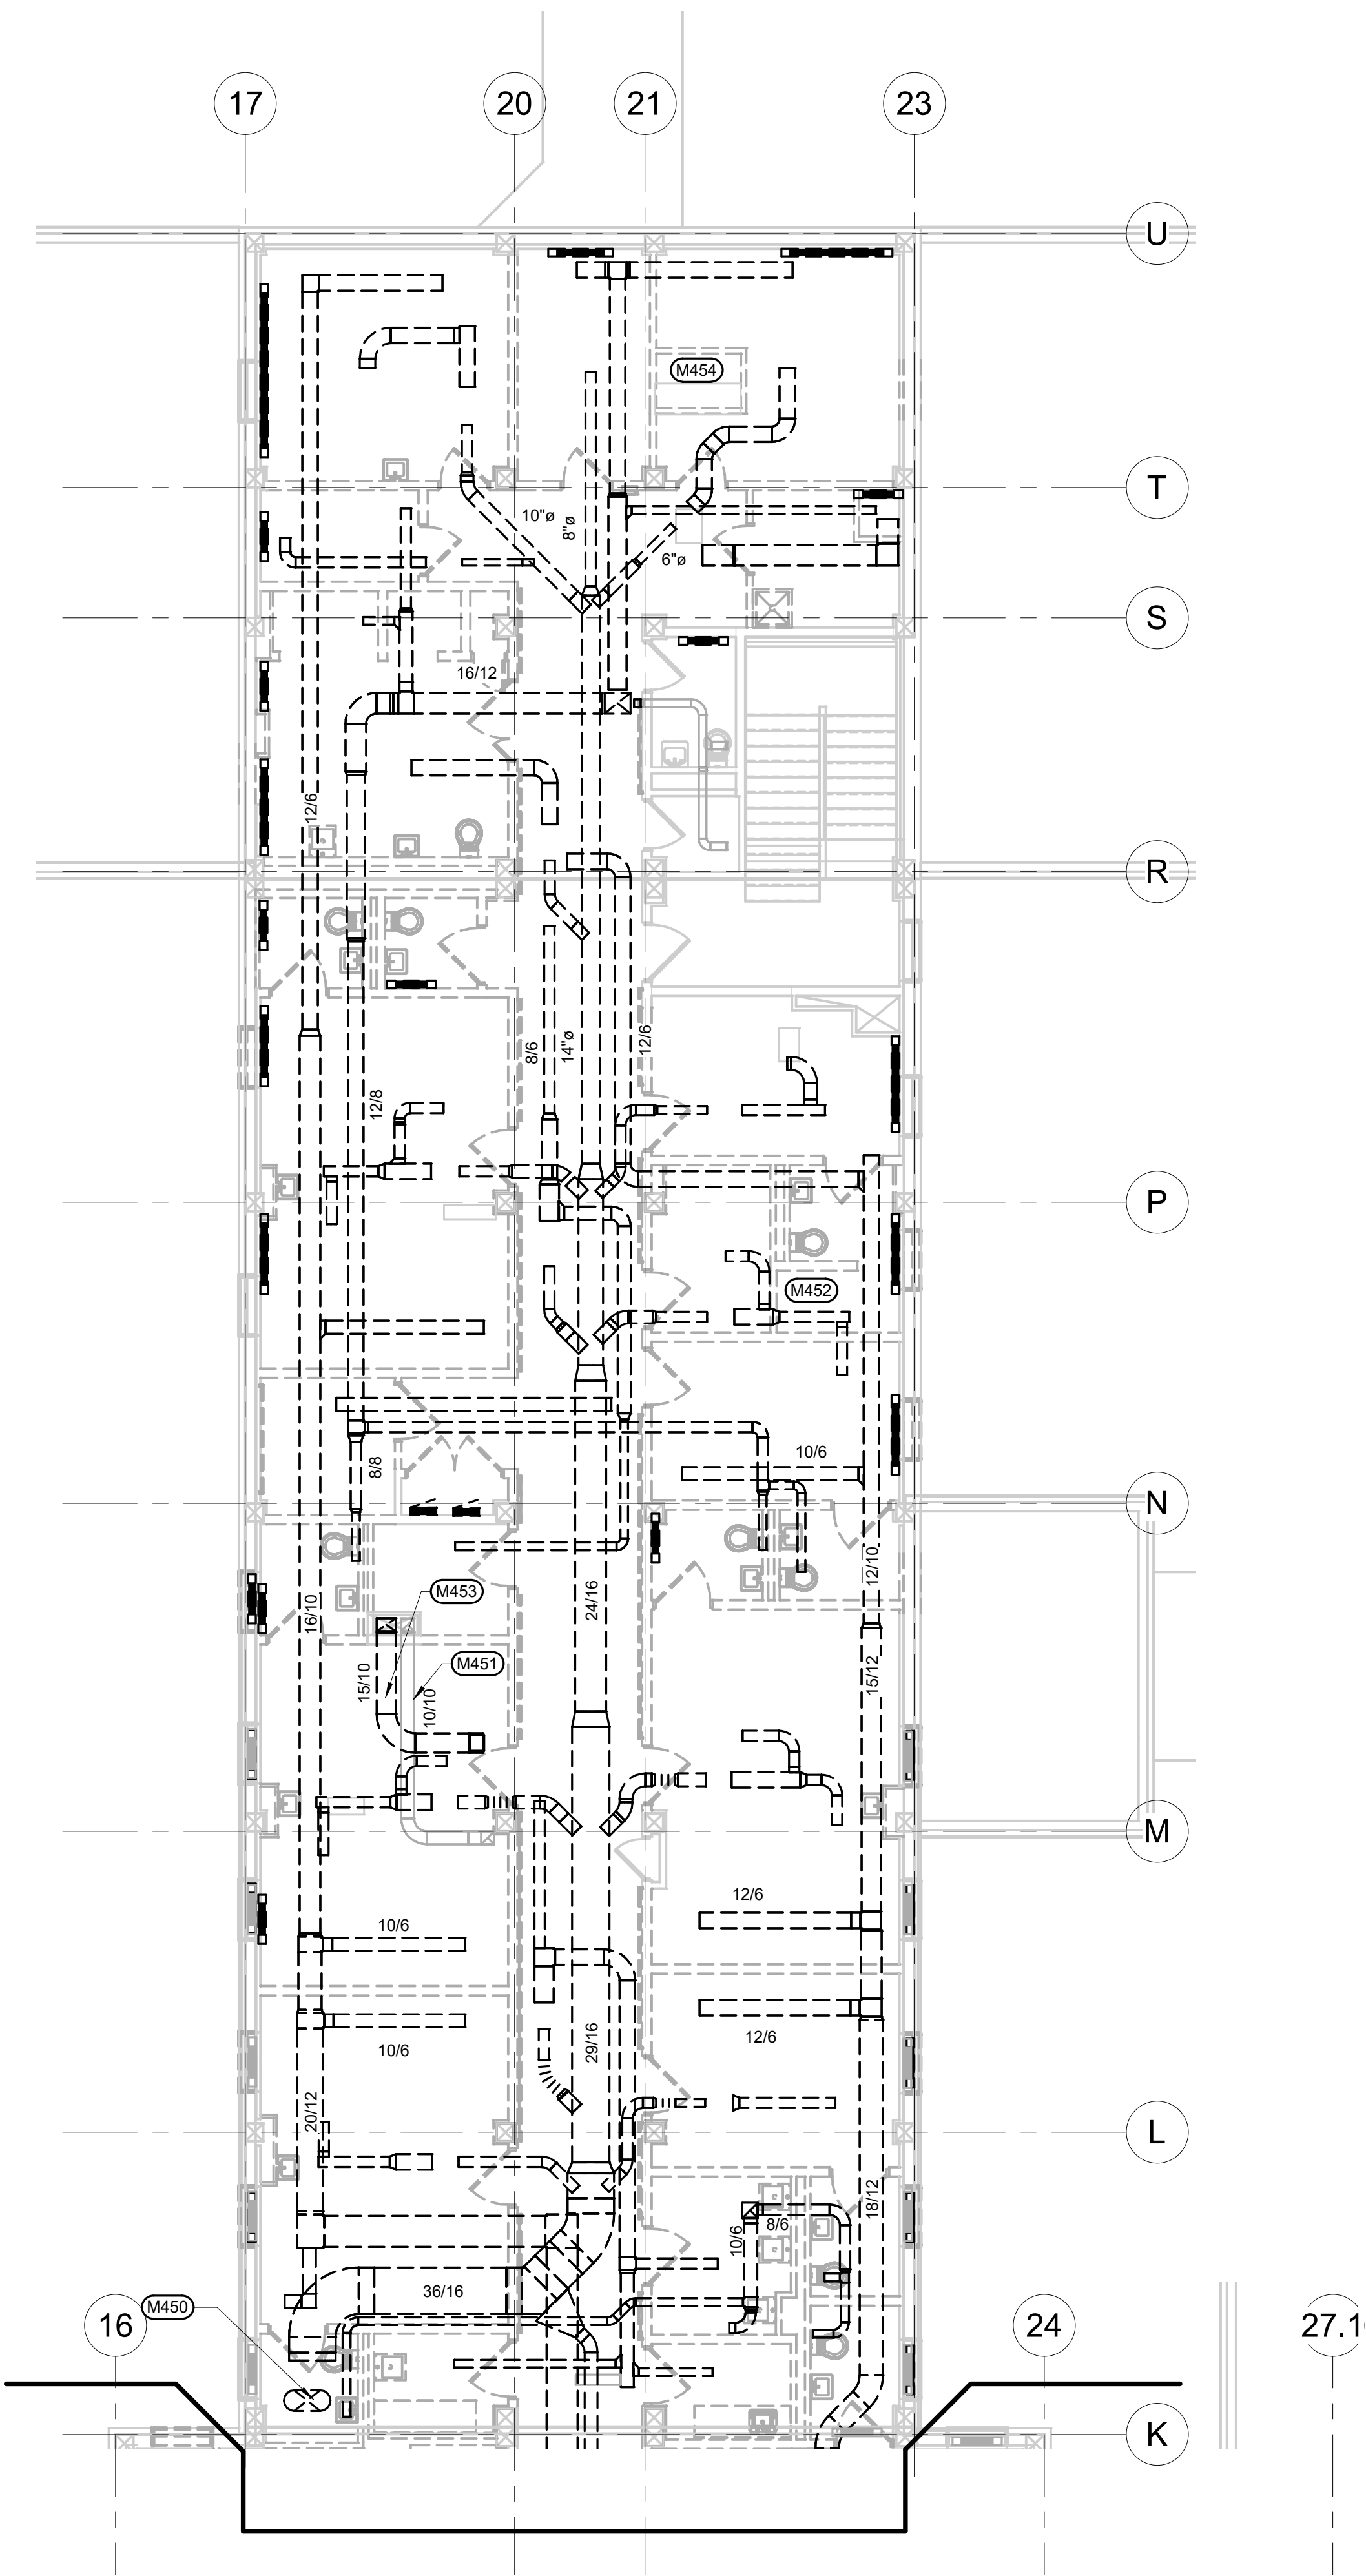

one eighth inch = one foot
one quarter inch = one foot
three eighths inch = one foot
one half inch = one foot
one inch = one foot
one and one half inches = one foot
three inches = one foot

C:\Revit\Local Files\2020\BR21020-RENOVATE AND CONSOLIDATE INPATIENT FUNCTIONS BUILDING 113\MEP20-CENTRAL_McReggie.rvt 6/10/2022 8:16:41 AM

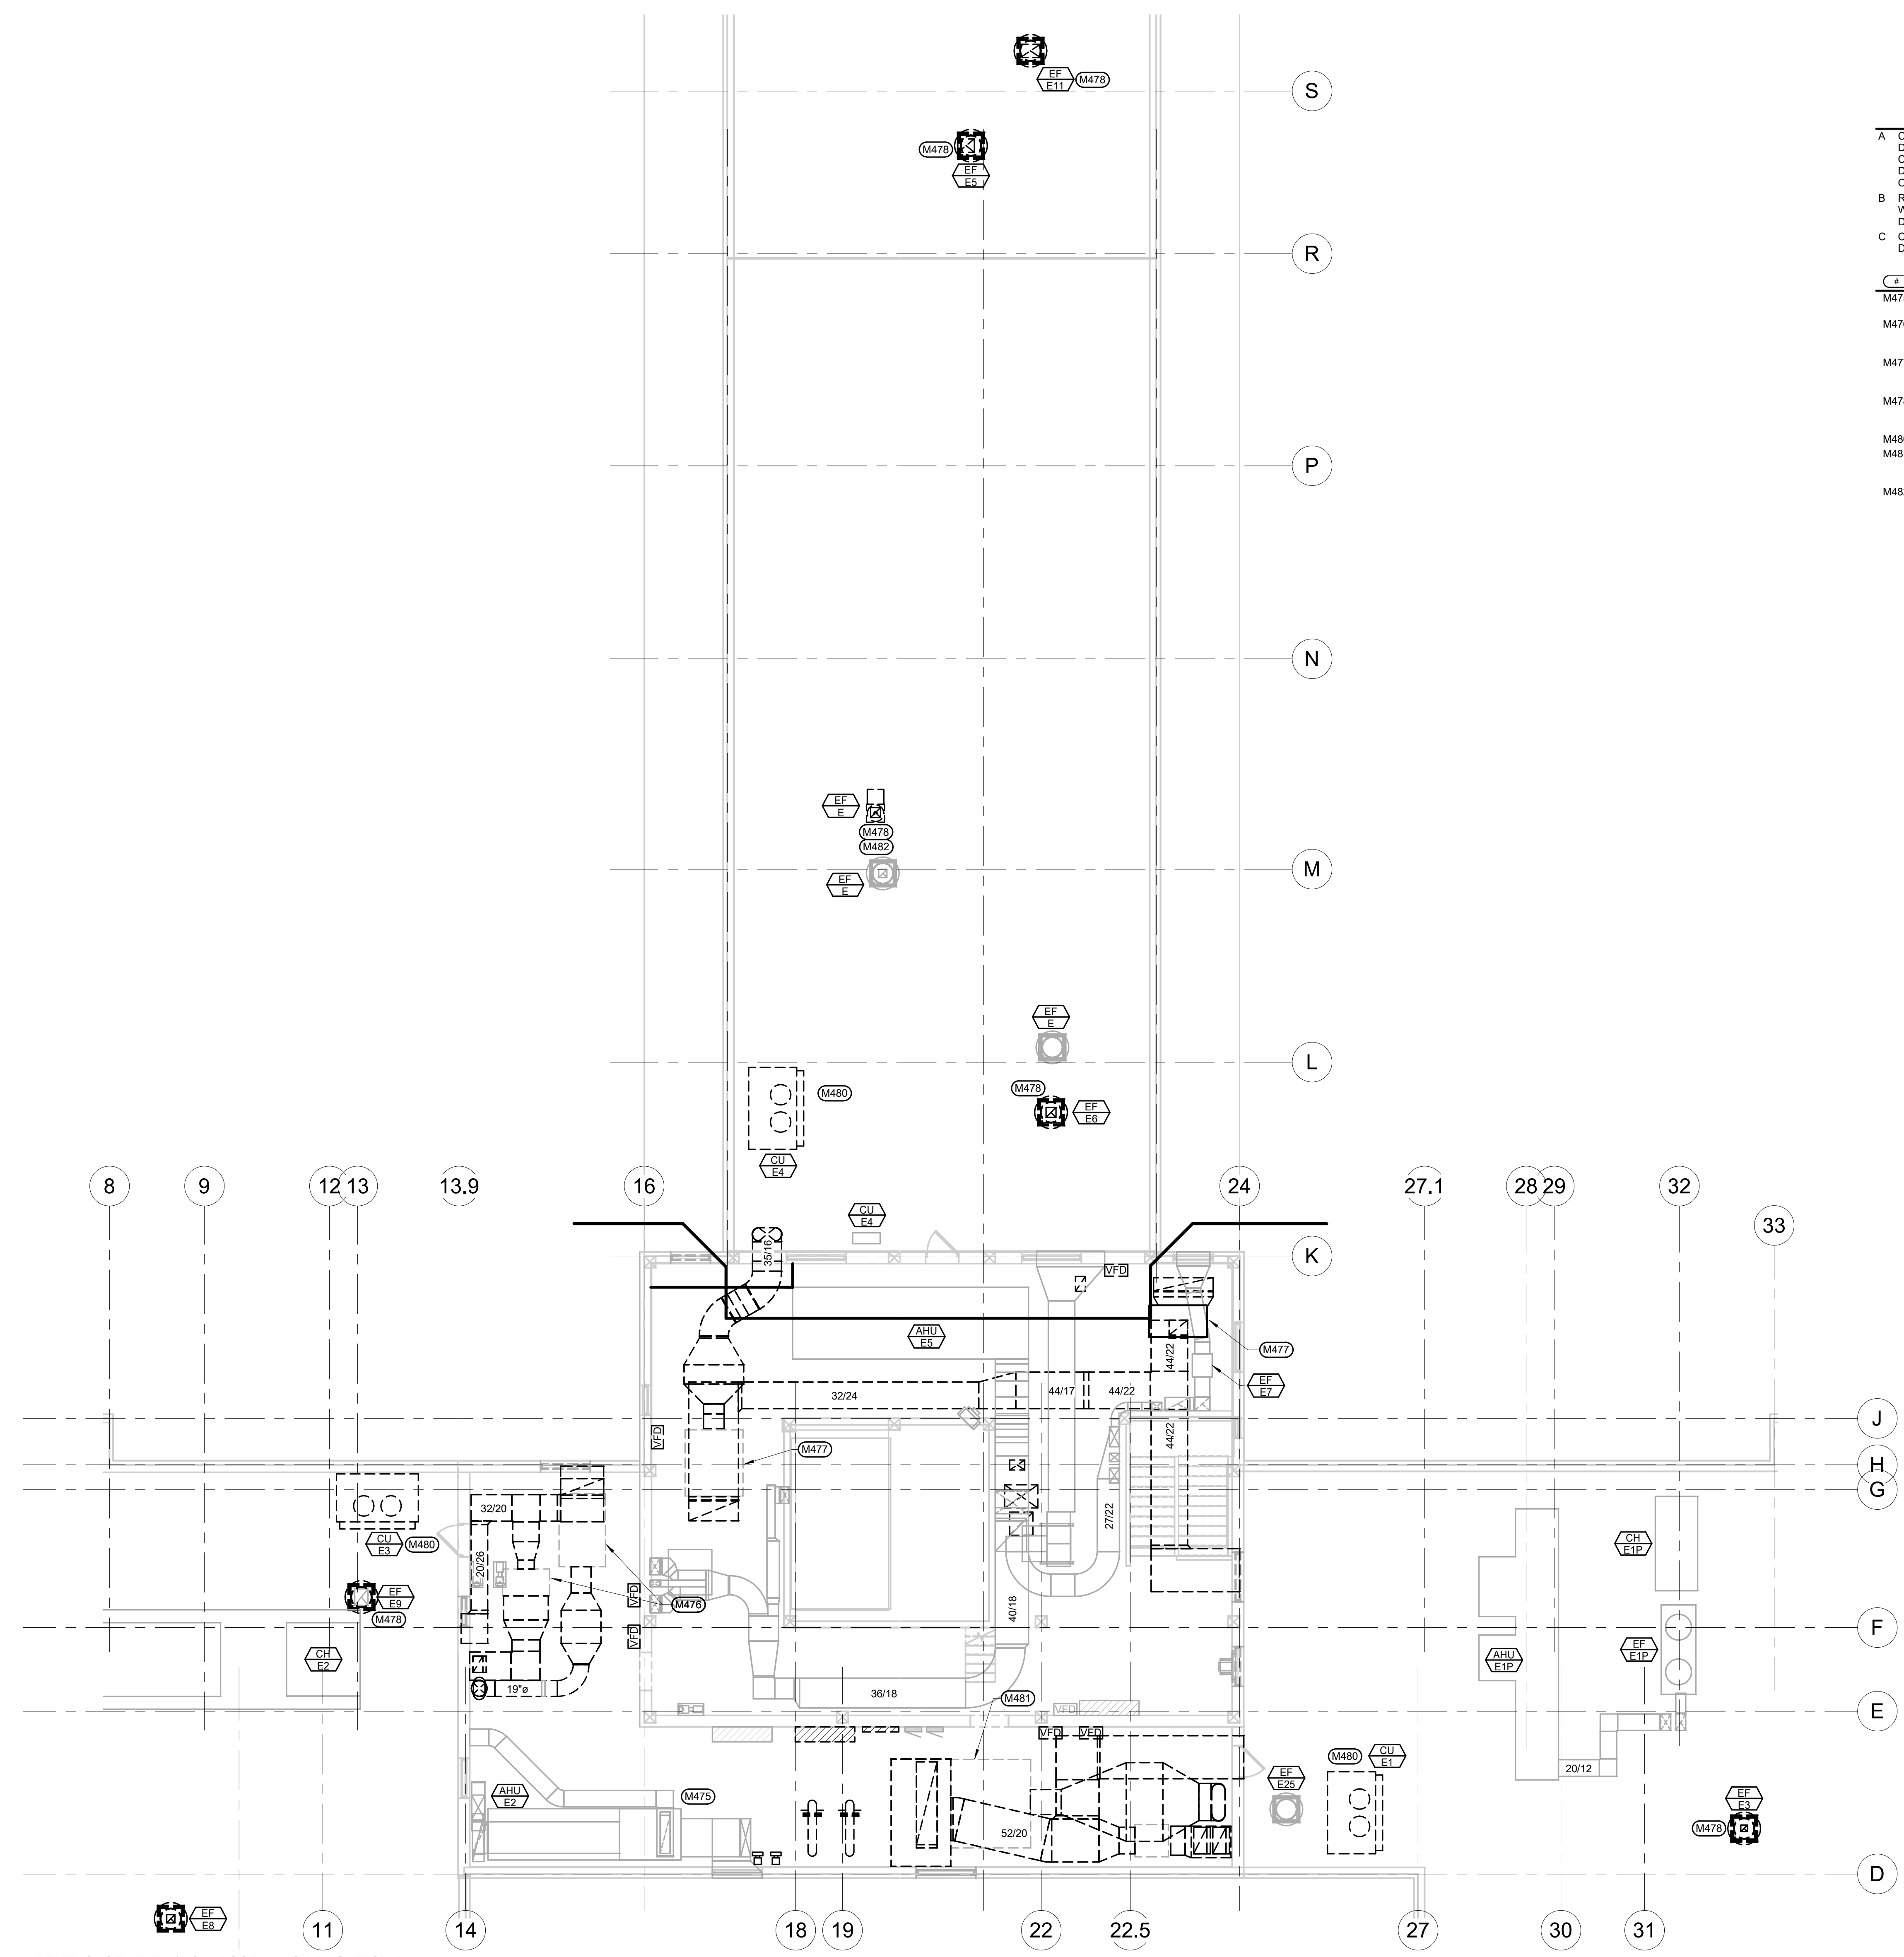

- GENERAL MECHANICAL NOTES**
- A. COORDINATE PHASING AND REMOVAL OF EXISTING DUCTWORK AND EQUIPMENT WITH OWNER. COORDINATE PHASING AND REMOVAL OF EXISTING DUCTWORK AND EQUIPMENT WITH CONTRACTING OFFICER.
 - B. REMOVE EXISTING DUCTWORK, EQUIPMENT, ETC. WHERE INDICATED BY HATCHING. CAP DUCTWORK DURING CONSTRUCTION.
 - C. CONTRACTOR TO CONFIRM LOCATIONS OF EXISTING DUCTWORK AND EQUIPMENT.
- MECHANICAL SPECIFIC NOTES**
- M475 EXISTING AIR HANDLING UNIT (AHU-E2) AND ASSOCIATED RETURN FAN (RF-E2) TO REMAIN.
 - M476 REMOVE EXISTING AHU-E3, RF-E3, AND ASSOCIATED DUCTWORK. CAP WALL PENETRATIONS DURING CONSTRUCTION.
 - M477 REMOVE EXISTING AHU-E4, RF-E4, AND ASSOCIATED DUCTWORK. CAP WALL PENETRATIONS DURING CONSTRUCTION.
 - M478 REMOVE EXISTING EXHAUST FAN AND ASSOCIATED DUCTWORK. CAP ROOF PENETRATION DURING CONSTRUCTION.
 - M480 REMOVE EXISTING CONDENSING UNIT.
 - M481 REMOVE EXISTING AHU-E1, RF-E1, AND ASSOCIATED DUCTWORK. CAP WALL PENETRATIONS DURING CONSTRUCTION.
 - M482 EXISTING FAN AND DUCTWORK SERVED CHEMOTHERAPY HOOD. REMOVE AND DISPOSE PER APPROPRIATE REQUIREMENTS.

Revision#	Description	Date:

CONSULTANTS

STRUCTURAL:

Albertson Engineering, Inc.
3302 W. Main St. #C
Rapid City, South Dakota 57702
Phone: 605-343-9606


MECHANICAL / ELECTRICAL / PLUMBING:

WPE WEST PLAINS ENGINEERING, INC.
1750 Rand Road
Rapid City, South Dakota 57702
Phone: 605-348-7455

ARCHITECT OF RECORD

A/E:
STONE GROUP ARCHITECTS, INC.
319 N. MAIN AVE.
SIOUX FALLS, SD 57104
605.271.1144
TODD STONE, AIA

STONE GROUP ARCHITECTS

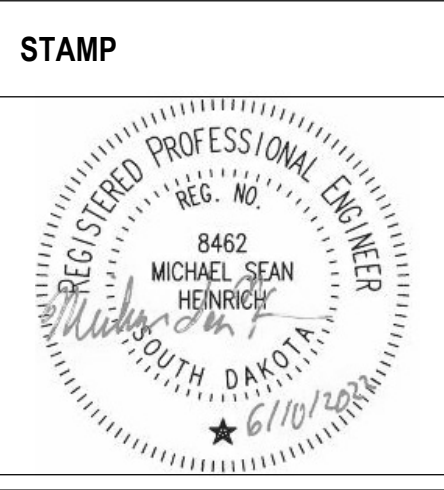

Office of Construction and Facilities Management

VA U.S. Department of Veterans Affairs

Drawing Title
PENTHOUSE LEVEL/ LOW ROOF HVAC DEMOLITION PLAN

Approved:

Phase
CONSTRUCTION DOCUMENTS

FULLY SPRINKLERED

Project Title
RENOVATE AND CONSOLIDATE INPATIENT FUNCTIONS

Location
FORT MEADE, SOUTH DAKOTA

Issue Date
06/10/2022

Checked
MSH

Drawn
MMM


Project Number
VA #568-14-110
WPE #BR21020

Building Number
113

Drawing Number
MD104

one eighth inch = one foot
one quarter inch = one foot
three eighths inch = one foot
one half inch = one foot
one inch = one foot
one and one half inches = one foot
two inches = one foot
three inches = one foot

C:\Revit\Local Files\2020\BR21020-RENOVATE AND CONSOLIDATE INPATIENT FUNCTIONS BUILDING 113\MEP20-CENTRAL_McReggie.rvt
6/10/2022 8:16:44 AM

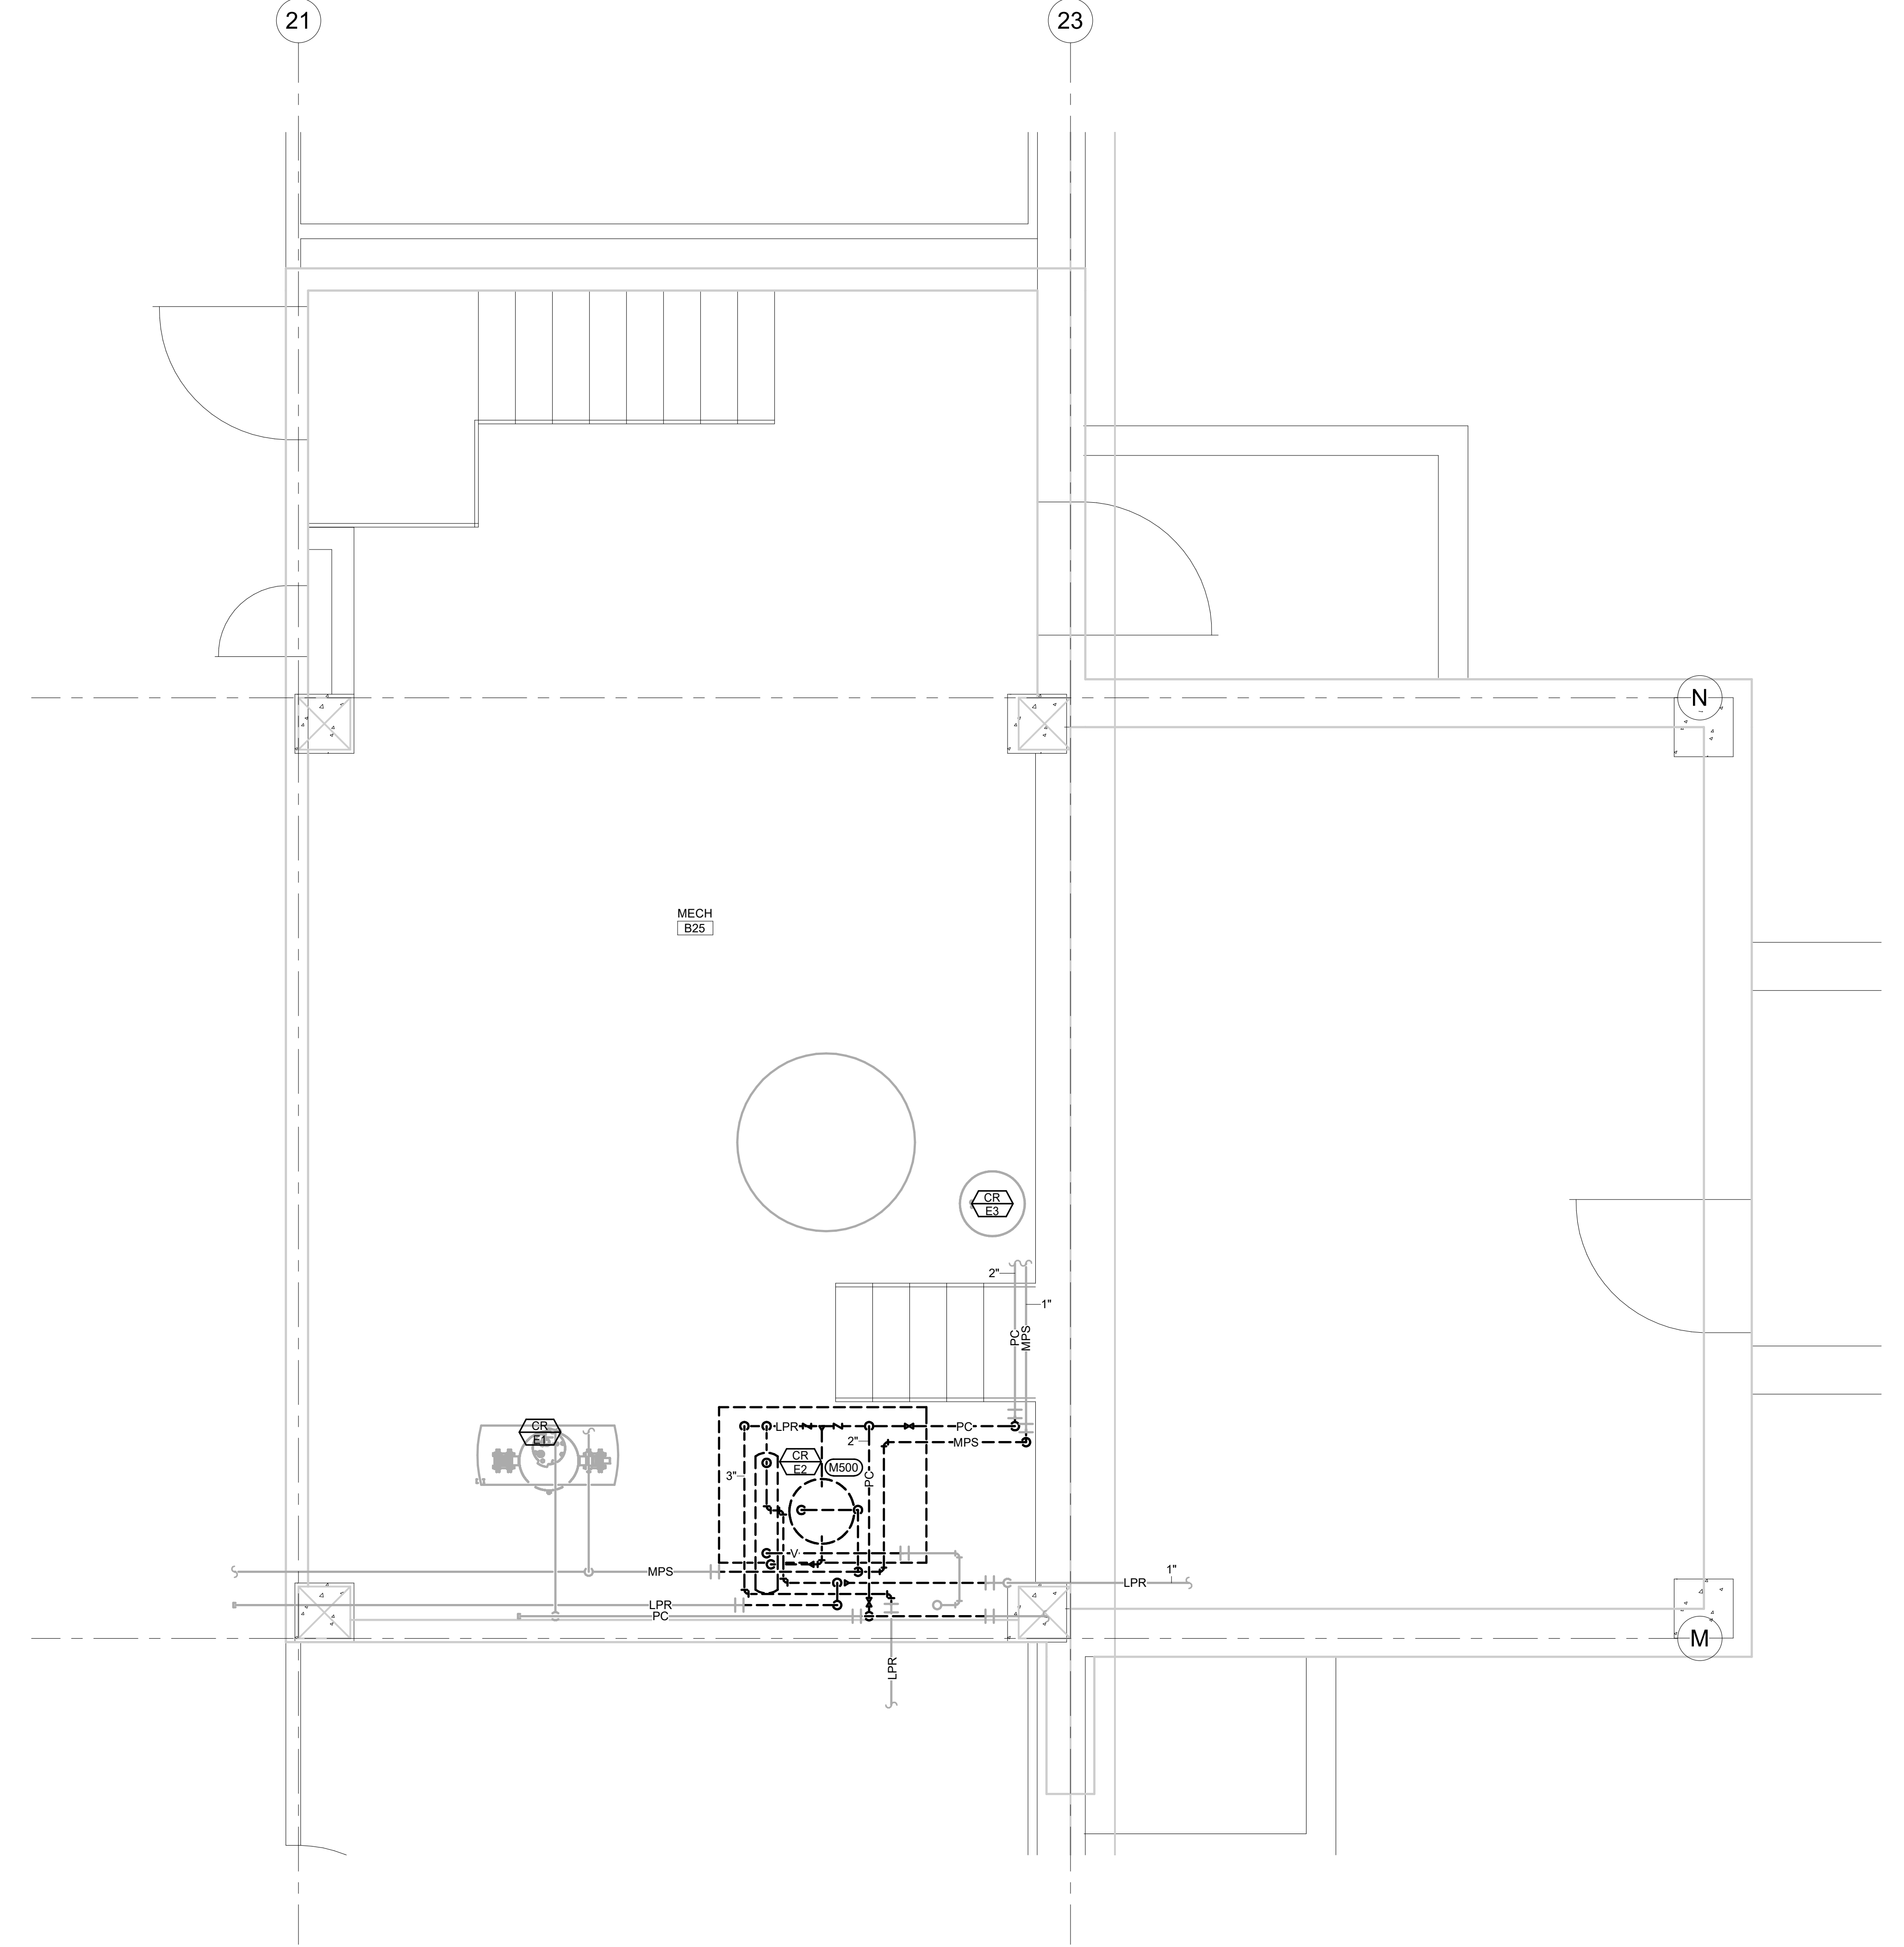

- GENERAL MECHANICAL NOTES**
- A COORDINATE PHASING AND REMOVAL OF EXISTING PIPING AND EQUIPMENT WITH OWNER.
 - B REMOVE EXISTING PIPING, EQUIPMENT, ETC. WHERE DASHED. CAP PIPING DURING CONSTRUCTION.
 - C CONTRACTOR TO CONFIRM LOCATIONS OF EXISTING PIPING AND EQUIPMENT.
- MECHANICAL SPECIFIC NOTES**
- M500 REMOVE EXISTING CONDENSATE PUMP, RECEIVER, AND ASSOCIATED PIPING AS INDICATED. OWNER HAS FIRST RIGHT OF REFUSAL ON EXISTING CONDENSATE PUMP AND RECEIVER. COORDINATE WITH OWNER PRIOR TO DEMOLITION.

1 PARTIAL BASEMENT HVAC PIPING DEMOLITION PLAN
1/2" = 1'-0"

Revision#	Description	Date:

CONSULTANTS

STRUCTURAL:
Albertson Engineering, Inc.
3302 W. Main St. #C
Rapid City, South Dakota 57702
Phone: 605-343-9606

MECHANICAL / ELECTRICAL / PLUMBING:
WPE
West Plains Engineering, Inc.
1750 Rand Road
Rapid City, South Dakota 57702
Phone: 605-348-7455

ARCHITECT OF RECORD

A/E:
STONE GROUP ARCHITECTS, INC.
319 N. MAIN AVE.
SIOUX FALLS, SD 57104
605.271.1144
TODD STONE, AIA

STONE GROUP ARCHITECTS

STAMP

REGISTERED PROFESSIONAL ENGINEER
REG. NO. 8462
MICHAEL SEAN HENNINGER
SOUTH DAKOTA
6/10/2022

Office of Construction and Facilities Management

VA U.S. Department of Veterans Affairs

Drawing Title
PARTIAL BASEMENT HVAC PIPING DEMOLITION PLAN

Approved:

Phase
CONSTRUCTION DOCUMENTS

FULLY SPRINKLERED

Project Title
RENOVATE AND CONSOLIDATE INPATIENT FUNCTIONS

Location
FORT MEADE, SOUTH DAKOTA

Issue Date
06/10/2022


Checked
MSH

Drawn
MMM

Project Number
VA #568-14-110
WPE #BR21020

Building Number
113

Drawing Number
MD105

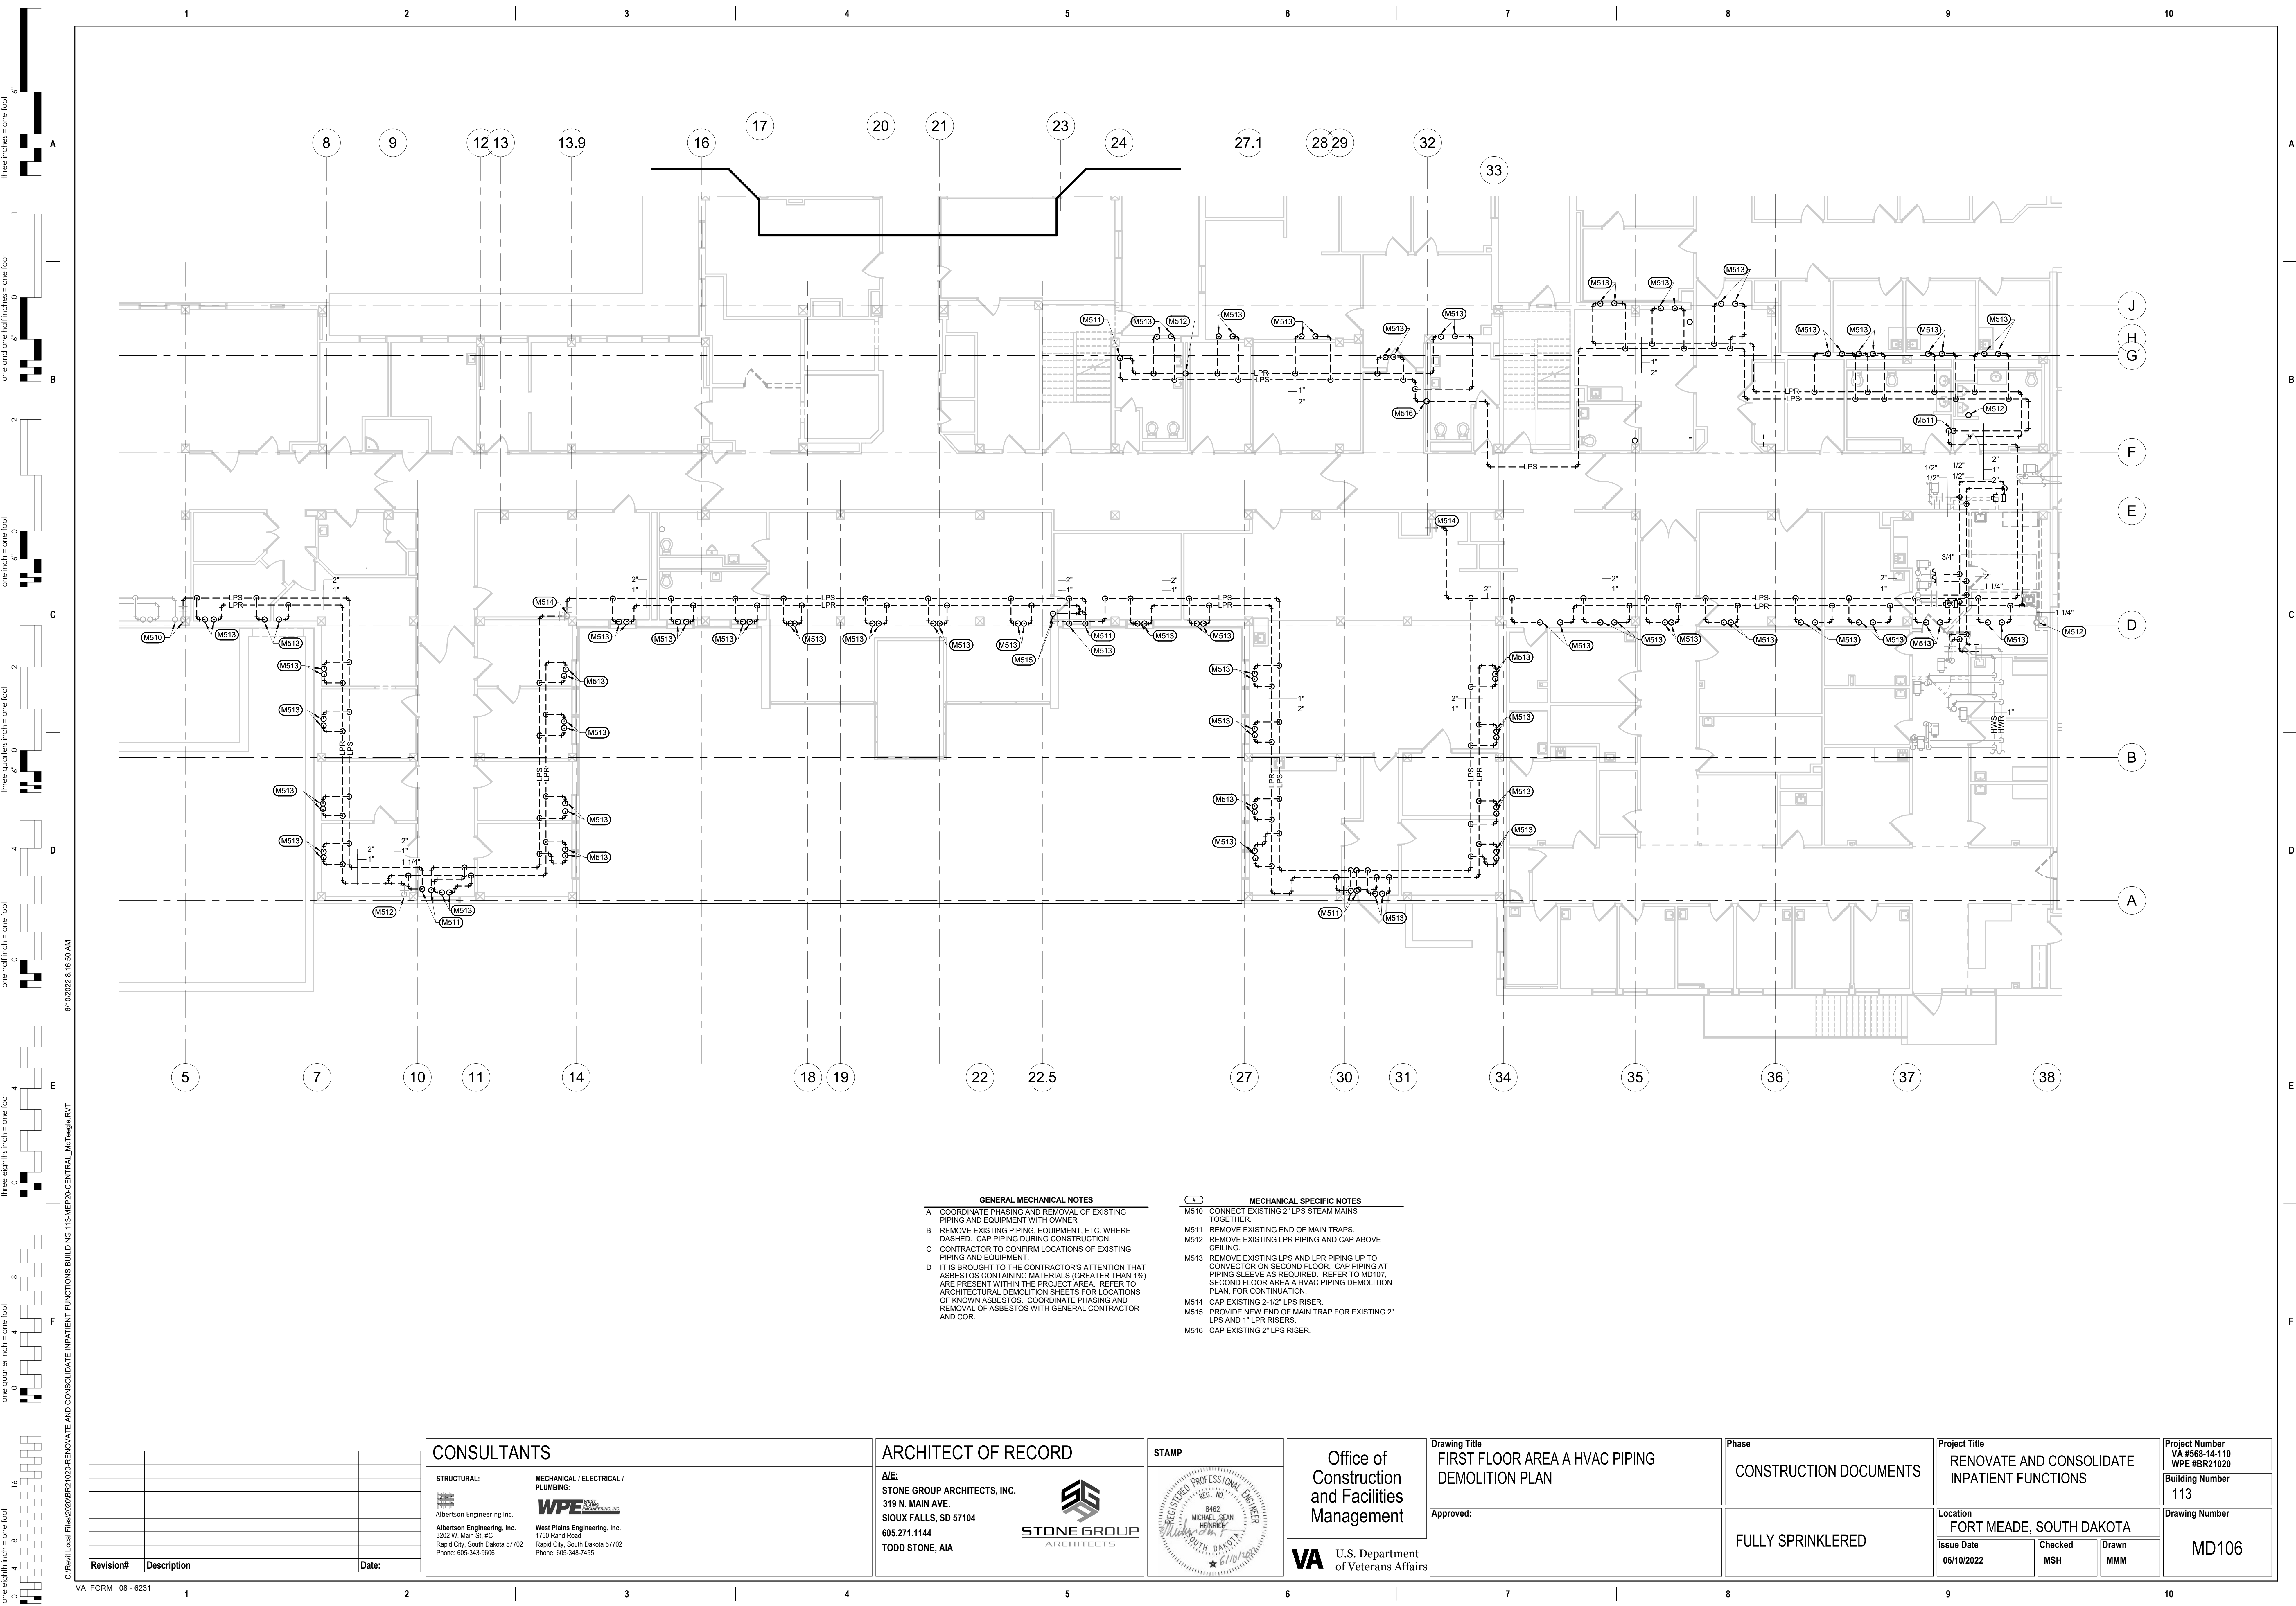

GENERAL MECHANICAL NOTES

- A. COORDINATE PHASING AND REMOVAL OF EXISTING PIPING AND EQUIPMENT WITH OWNER.
- B. REMOVE EXISTING PIPING, EQUIPMENT, ETC. WHERE DASHED. CAP PIPING DURING CONSTRUCTION.
- C. CONTRACTOR TO CONFIRM LOCATIONS OF EXISTING PIPING AND EQUIPMENT.
- D. IT IS BROUGHT TO THE CONTRACTOR'S ATTENTION THAT ASBESTOS CONTAINING MATERIALS (GREATER THAN 1%) ARE PRESENT WITHIN THE PROJECT AREA. REFER TO ARCHITECTURAL DEMOLITION SHEETS FOR LOCATIONS OF KNOWN ASBESTOS. COORDINATE PHASING AND REMOVAL OF ASBESTOS WITH GENERAL CONTRACTOR AND COR.

MECHANICAL SPECIFIC NOTES

- M510. CONNECT EXISTING 2" LPS STEAM MAINS TOGETHER.
- M511. REMOVE EXISTING END OF MAIN TRAPS.
- M512. REMOVE EXISTING LPR PIPING AND CAP ABOVE CEILING.
- M513. REMOVE EXISTING LPS AND LPR PIPING UP TO CONVECTOR ON SECOND FLOOR. CAP PIPING AT PIPING SLEEVE AS REQUIRED. REFER TO M5107, SECOND FLOOR AREA A HVAC PIPING DEMOLITION PLAN, FOR CONTINUATION.
- M514. CAP EXISTING 2-1/2" LPS RISER.
- M515. PROVIDE NEW END OF MAIN TRAP FOR EXISTING 2" LPS AND 1" LPR RISERS.
- M516. CAP EXISTING 2" LPS RISER.

CONSULTANTS

STRUCTURAL:
Albertson Engineering, Inc.
3302 W. Main St. #C
Rapid City, South Dakota 57702
Phone: 605-343-9606


MECHANICAL / ELECTRICAL / PLUMBING:
West Plains Engineering, Inc.
1750 Rand Road
Rapid City, South Dakota 57702
Phone: 605-348-7455

ARCHITECT OF RECORD

A/E:
STONE GROUP ARCHITECTS, INC.
319 N. MAIN AVE.
SIOUX FALLS, SD 57104
605.271.1144
TODD STONE, AIA



STAMP

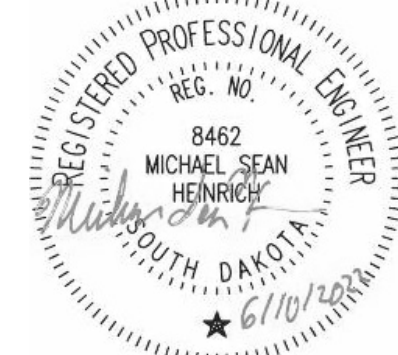

Office of
Construction
and Facilities
Management



U.S. Department
of Veterans Affairs

Drawing Title
FIRST FLOOR AREA A HVAC PIPING
DEMOLITION PLAN

Approved:

Phase
CONSTRUCTION DOCUMENTS

FULLY SPRINKLERED

Project Title
RENOVATE AND CONSOLIDATE
INPATIENT FUNCTIONS

Location
FORT MEADE, SOUTH DAKOTA

Issue Date
06/10/2022

Checked
MSH


Drawn
MMM

Project Number
VA #568-14-110
WPE #BR21020
Building Number
113


Drawing Number
MD106

three inches = one foot
one and one half inches = one foot
one inch = one foot
three quarters inch = one foot
one half inch = one foot
one quarter inch = one foot
three eighths inch = one foot
one eighth inch = one foot

C:\Revit\Local Files\2020\08\21\1020-RENOVATE AND CONSOLIDATE INPATIENT FUNCTIONS BUILDING 1154\MEP20-CENTRAL_McReggie.rvt 6/10/2022 8:16:53 AM

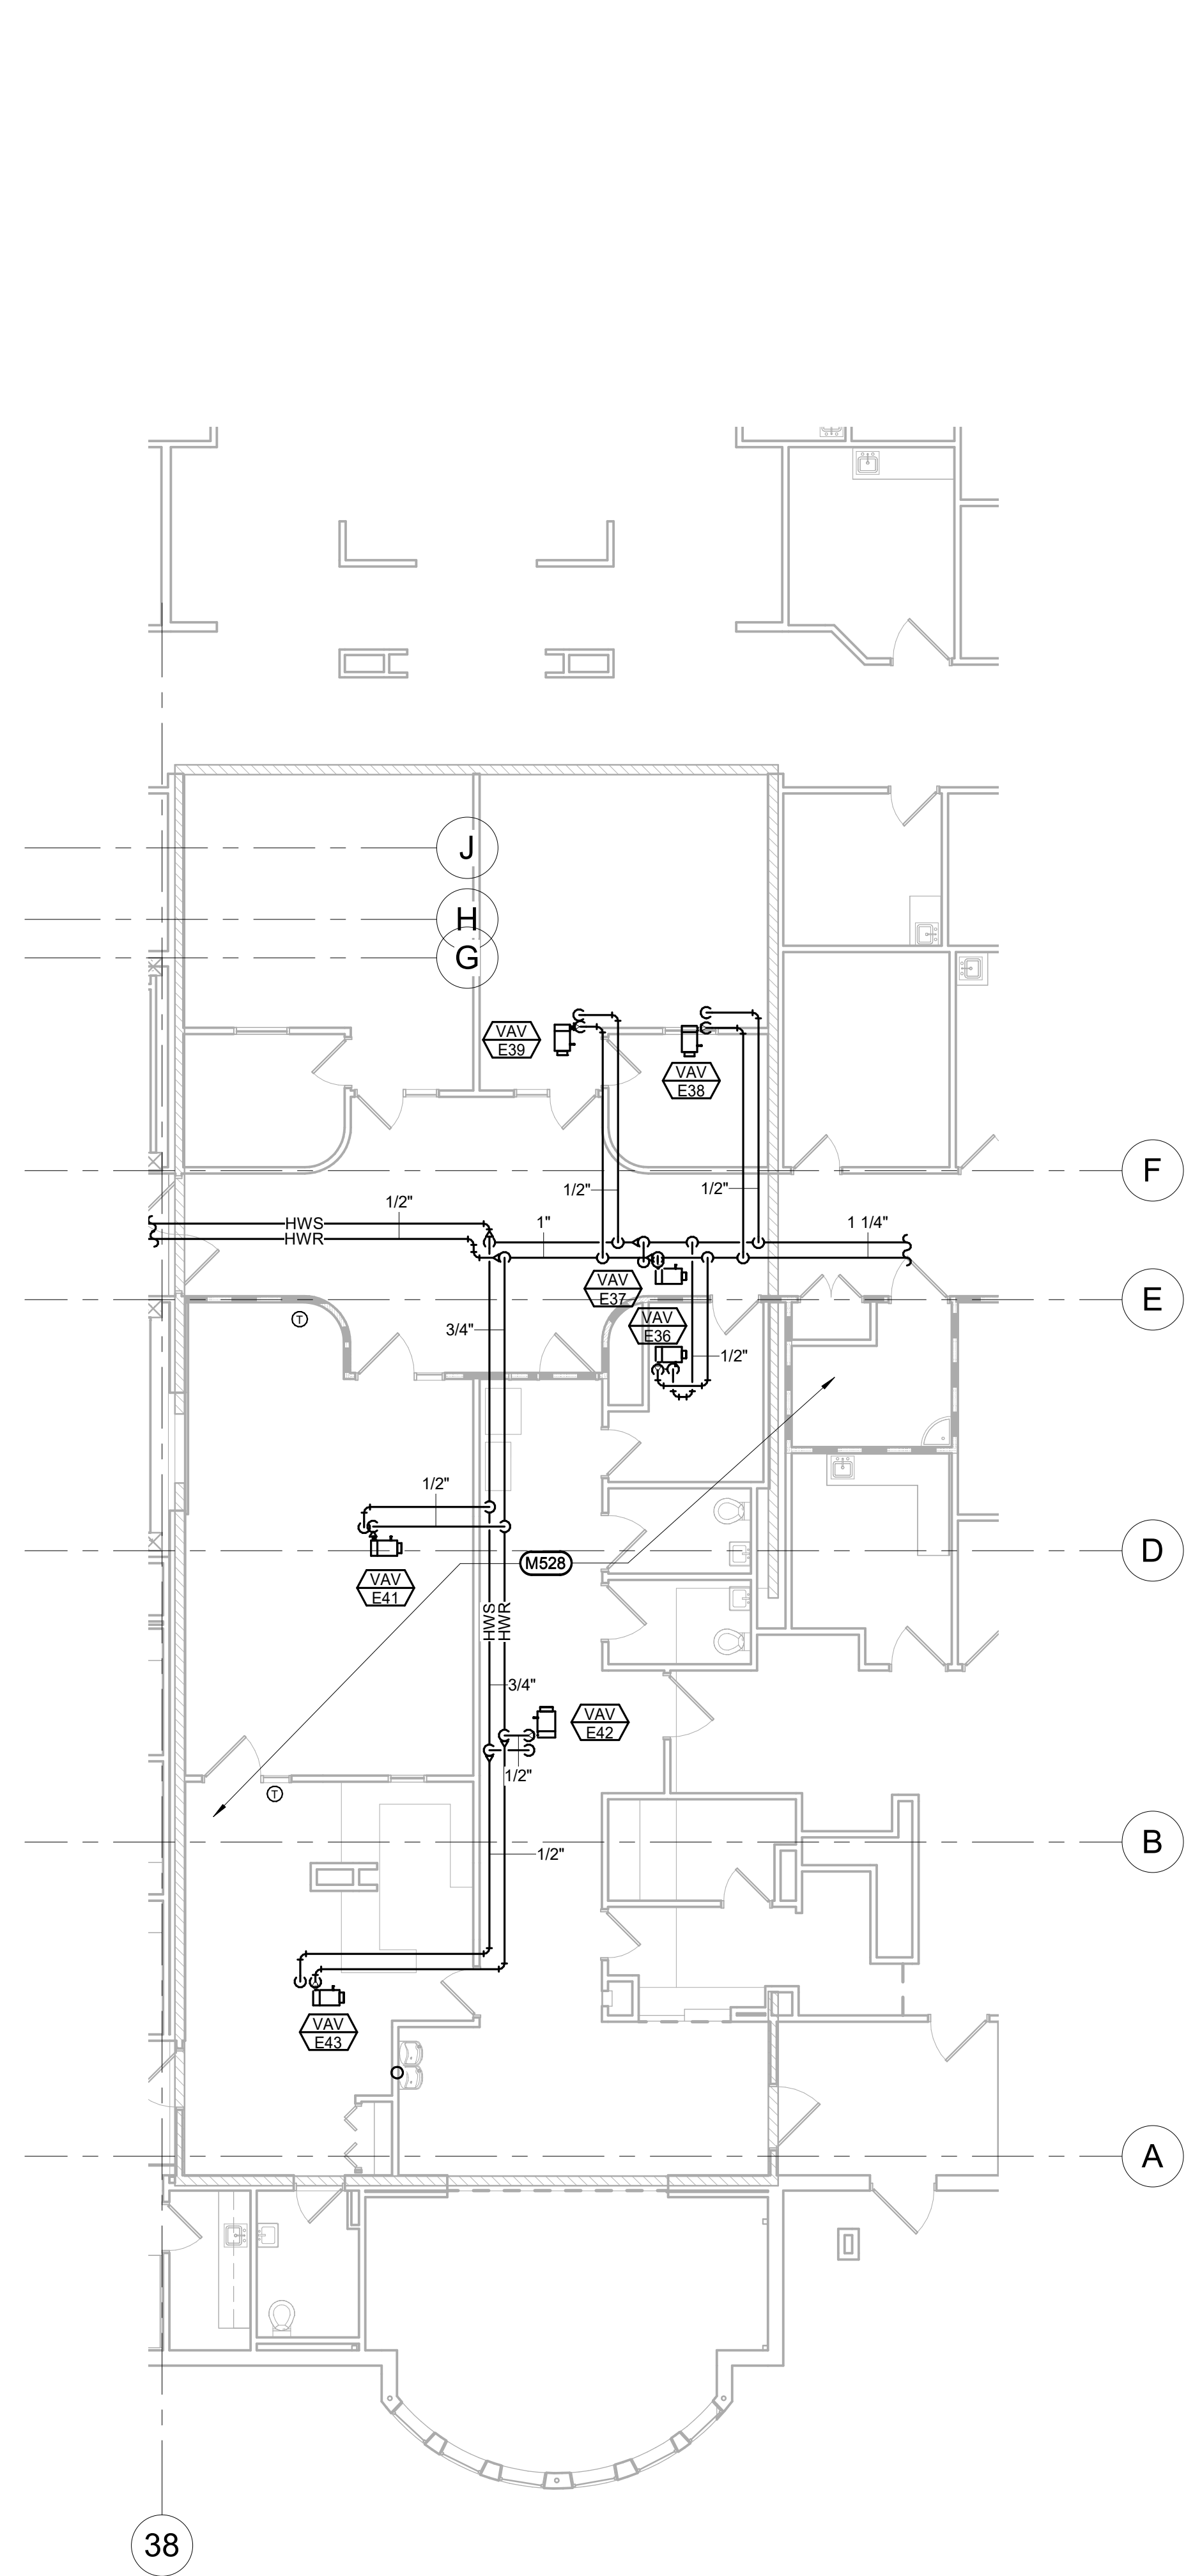

1 FIRST FLOOR AREA C HVAC PIPING DEMOLITION PLAN
1/8" = 1'-0"

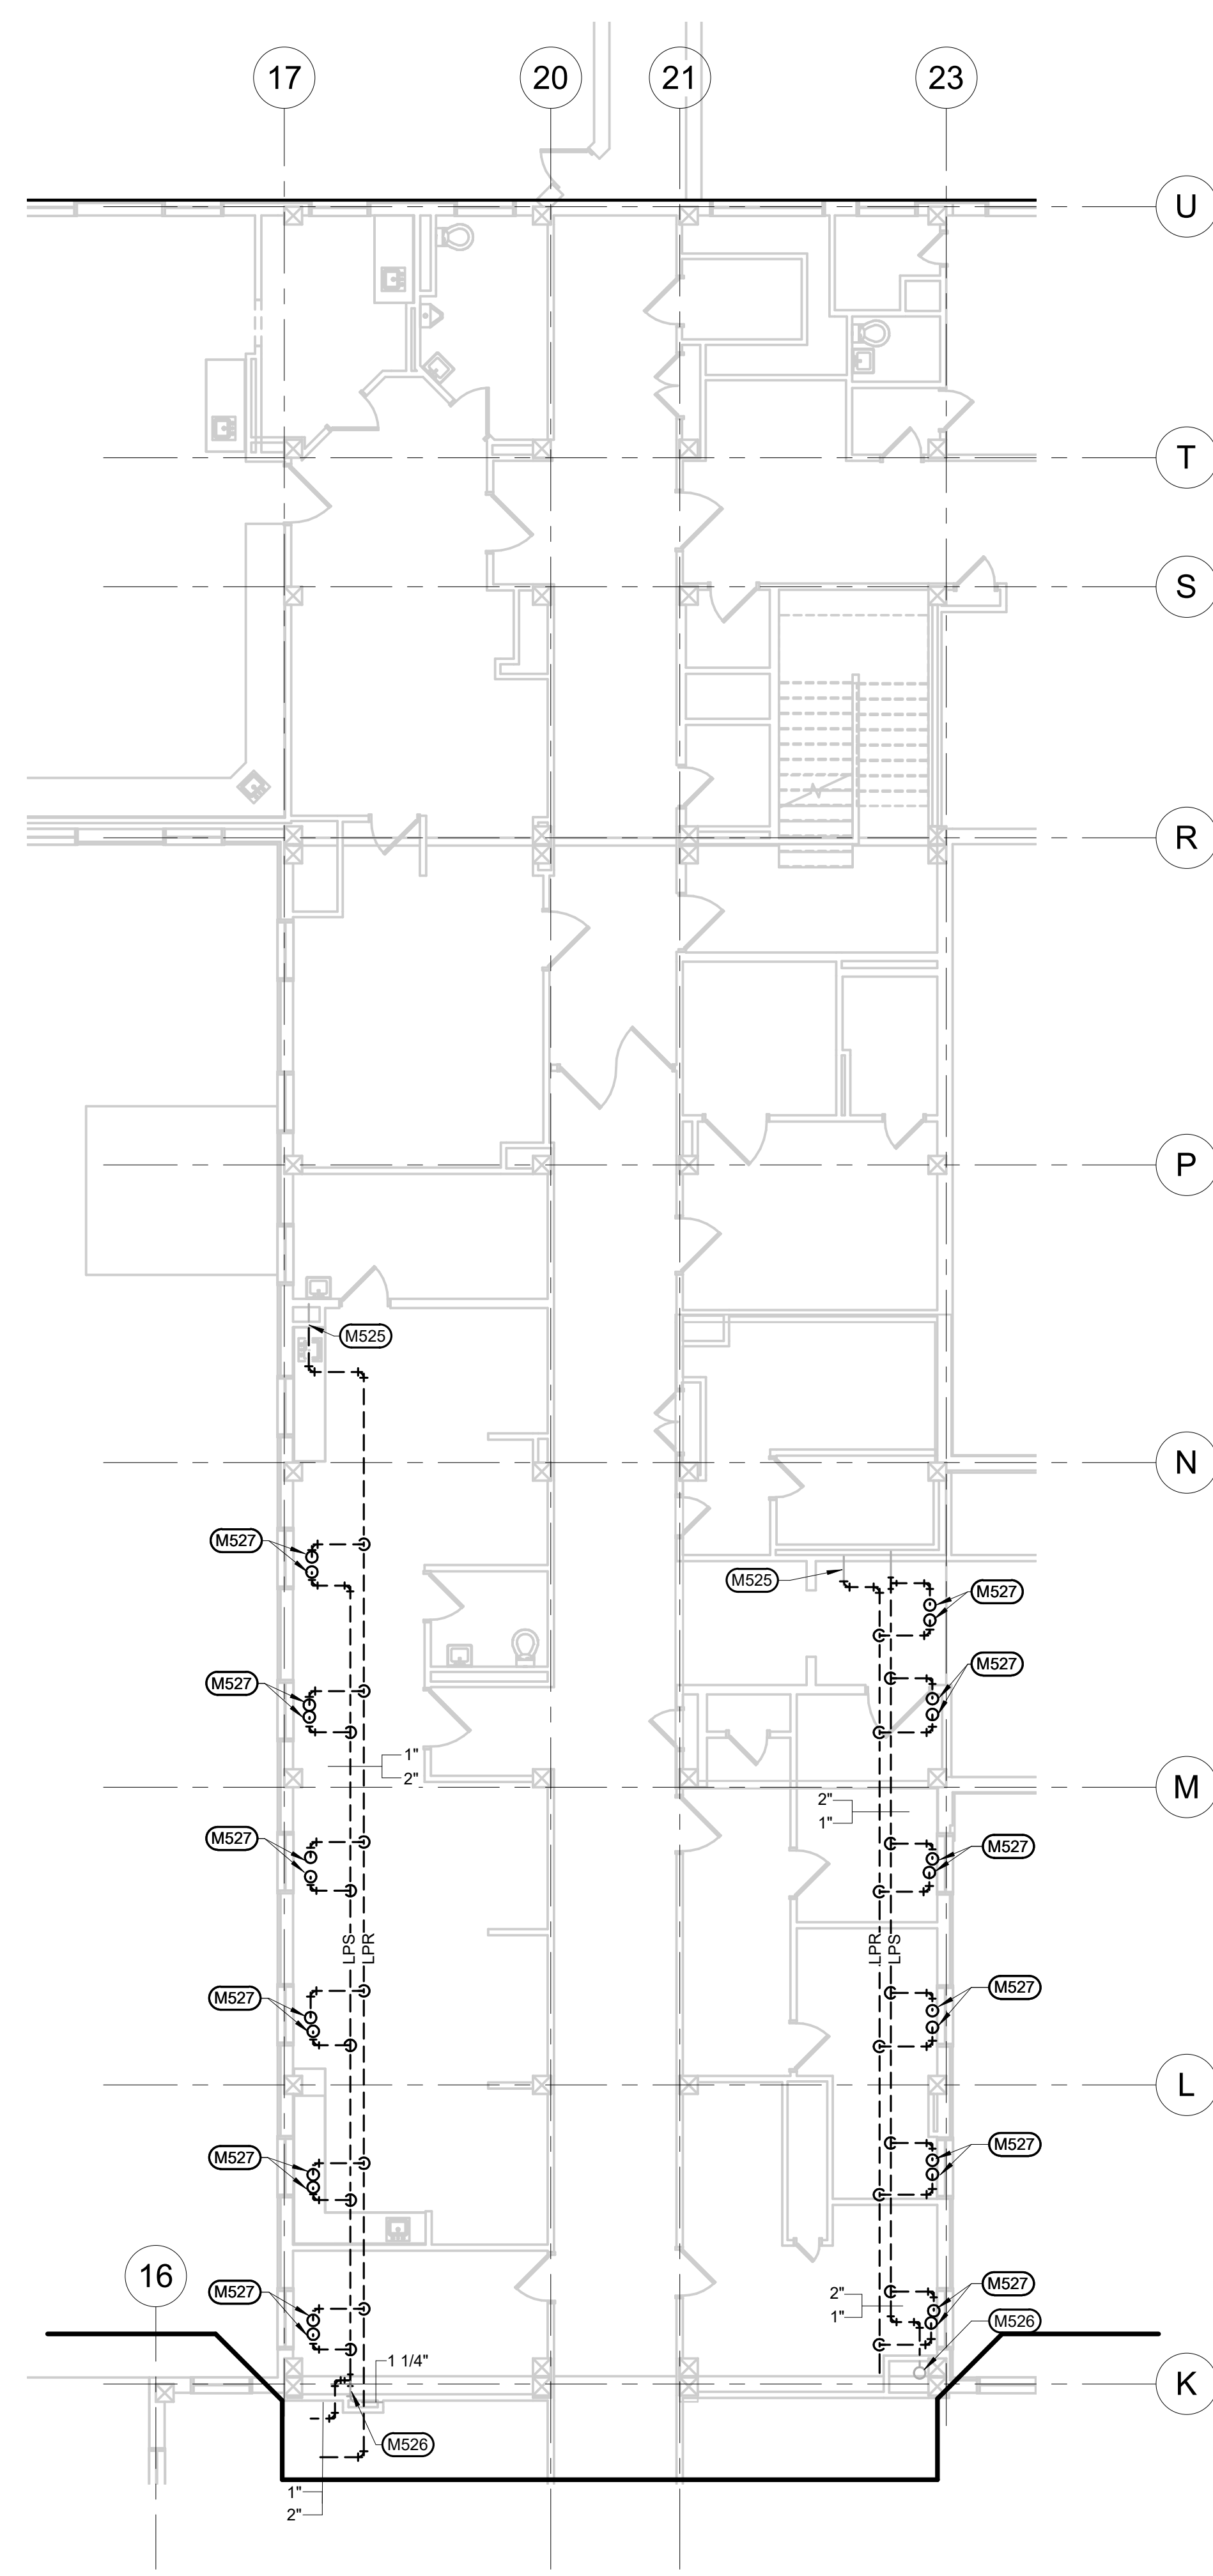

2 FIRST FLOOR AREA B HVAC PIPING DEMOLITION PLAN
1/8" = 1'-0"

- GENERAL MECHANICAL NOTES**
- A. COORDINATE PHASING AND REMOVAL OF EXISTING PIPING AND EQUIPMENT WITH OWNER
 - B. REMOVE EXISTING PIPING, EQUIPMENT, ETC. WHERE DASHED. CAP PIPING DURING CONSTRUCTION.
 - C. CONTRACTOR TO CONFIRM LOCATIONS OF EXISTING PIPING AND EQUIPMENT
 - D. IT IS BROUGHT TO THE CONTRACTOR'S ATTENTION THAT ASBESTOS CONTAINING MATERIALS (GREATER THAN 1%) ARE PRESENT WITHIN THE PROJECT AREA. REFER TO ARCHITECTURAL DEMOLITION SHEETS FOR LOCATIONS OF KNOWN ASBESTOS. COORDINATE PHASING AND REMOVAL OF ASBESTOS WITH GENERAL CONTRACTOR AND COR.
- MECHANICAL SPECIFIC NOTES**
- M525 CAP EXISTING 2" LPS RISER
 - M526 REMOVE EXISTING LPR PIPING AND CAP ABOVE CEILING.
 - M527 REMOVE EXISTING LPS AND LPR PIPING UP TO CONNECTOR ON SECOND FLOOR. CAP PIPING AT PIPING SLEEVE AS REQUIRED. REFER TO MD108, SECOND FLOOR AREA B & C HVAC PIPING DEMOLITION PLAN, FOR CONTINUATION.
 - M528 EXISTING HWS AND HWR PIPING WITHIN THIS AREA TO REMAIN IN OPERATION.

Revision#	Description	Date:

CONSULTANTS


STRUCTURAL:
Albertson Engineering, Inc.
3302 W. Main St. #C
Rapid City, South Dakota 57702
Phone: 605-343-9606

MECHANICAL / ELECTRICAL / PLUMBING:
WPE WEST PLAINS ENGINEERING, INC.
1750 Rand Road
Rapid City, South Dakota 57702
Phone: 605-348-7455

ARCHITECT OF RECORD

A/E:
STONE GROUP ARCHITECTS, INC.
319 N. MAIN AVE.
SIOUX FALLS, SD 57104
605.271.1144
TODD STONE, AIA

STONE GROUP ARCHITECTS

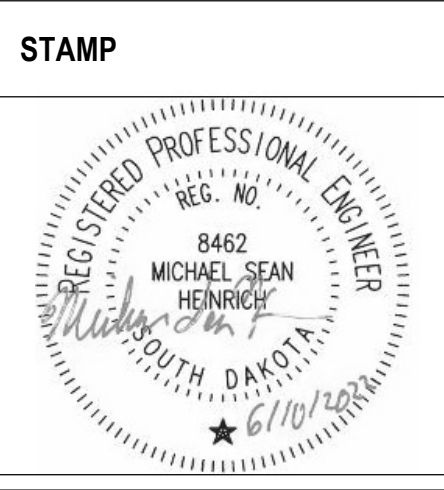

Office of Construction and Facilities Management

VA U.S. Department of Veterans Affairs

Drawing Title
FIRST FLOOR AREA B & C HVAC PIPING DEMOLITION PLAN

Approved:

Phase
CONSTRUCTION DOCUMENTS

FULLY SPRINKLERED

Project Title
RENOVATE AND CONSOLIDATE INPATIENT FUNCTIONS

Location
FORT MEADE, SOUTH DAKOTA

Issue Date
06/10/2022

Checked
MSH

Drawn
MMM

Project Number
VA #568-14-110
WPE #BR21020

Building Number
113

Drawing Number
MD107



- | # | MECHANICAL SPECIFIC NOTES |
|------|--|
| M550 | 1-1/2" LPR PIPING DOWN FROM EXISTING HEAT EXCHANGERS. |
| M551 | 2-1/2" HWS AND HWR PIPING UP TO PENTHOUSE. |
| M552 | 2-1/2" LPS RISER. |
| M553 | REMOVE EXISTING STEAM CONVECTOR AND ASSOCIATED PIPING. |
| M554 | REMOVE EXISTING FINNED TUBE RADIATION (RAD) AND ASSOCIATED PIPING. |

CONSULTANTS

STRUCTURAL:

Albertson Engineering Inc.
3022 W. Main St. #C
Rapid City, South Dakota 57702
Phone: 605-343-6606

MECHANICAL / ELECTRICAL / PLUMBING:

West Plains Engineering, Inc.
1750 Rand Road
Rapid City, South Dakota 57702
Phone: 605-348-7455



Office of
Construction
and Facilities
Management

VA U.S. Department
of Veterans Affairs

Phase

CONSTRUCTION DOCUMENTS

FULLY SPRINKLERED

Project Title RENOVATE AND CONSOLIDATE INPATIENT FUNCTIONS			Project Number VA #568-14-110 WPE #BR21020	
Location FORT MEADE, SOUTH DAKOTA			Building Number 113	
Issue Date 06/10/2022			Checked MSH	
Drawn MMM			MD108	

one eighth inch = one foot
one quarter inch = one foot
three eighths inch = one foot
one half inch = one foot
three quarters inch = one foot
one inch = one foot
one and one half inches = one foot
three inches = one foot

C:\Revit\Local Files\2020\BR21020-RENOVATE AND CONSOLIDATE INPATIENT FUNCTIONS BUILDING 113\MEP20-CENTRAL_McReggie.rvt 6/10/2022 8:17:02 AM

Revision#	Description	Date:

CONSULTANTS

STRUCTURAL:

Albertson Engineering, Inc.
3302 W. Main St. #C
Rapid City, South Dakota 57702
Phone: 605-343-9606

MECHANICAL / ELECTRICAL / PLUMBING:

West Plains Engineering, Inc.
1750 Rand Road
Rapid City, South Dakota 57702
Phone: 605-348-7455

ARCHITECT OF RECORD

A/E:
STONE GROUP ARCHITECTS, INC.
319 N. MAIN AVE.
SIOUX FALLS, SD 57104
605.271.1144
TODD STONE, AIA

STONE GROUP
ARCHITECTS

STAMP

Office of Construction and Facilities Management

U.S. Department of Veterans Affairs

Drawing Title

SECOND FLOOR AREA B & C HVAC PIPING DEMOLITION PLAN

Approved:

Phase

CONSTRUCTION DOCUMENTS

FULLY SPRINKLERED

Project Title

RENOVATE AND CONSOLIDATE INPATIENT FUNCTIONS

Location

FORT MEADE, SOUTH DAKOTA

Issue Date

06/10/2022

Checked

MSH

Drawn

MMM

Project Number

VA #568-14-110
WPE #BR21020

Building Number

113

Drawing Number

MD109

1 SECOND FLOOR AREA B HVAC DEMOLITION PIPING PLAN
1/8" = 1'-0"

