
 


FOURTH FLOOR PLAN

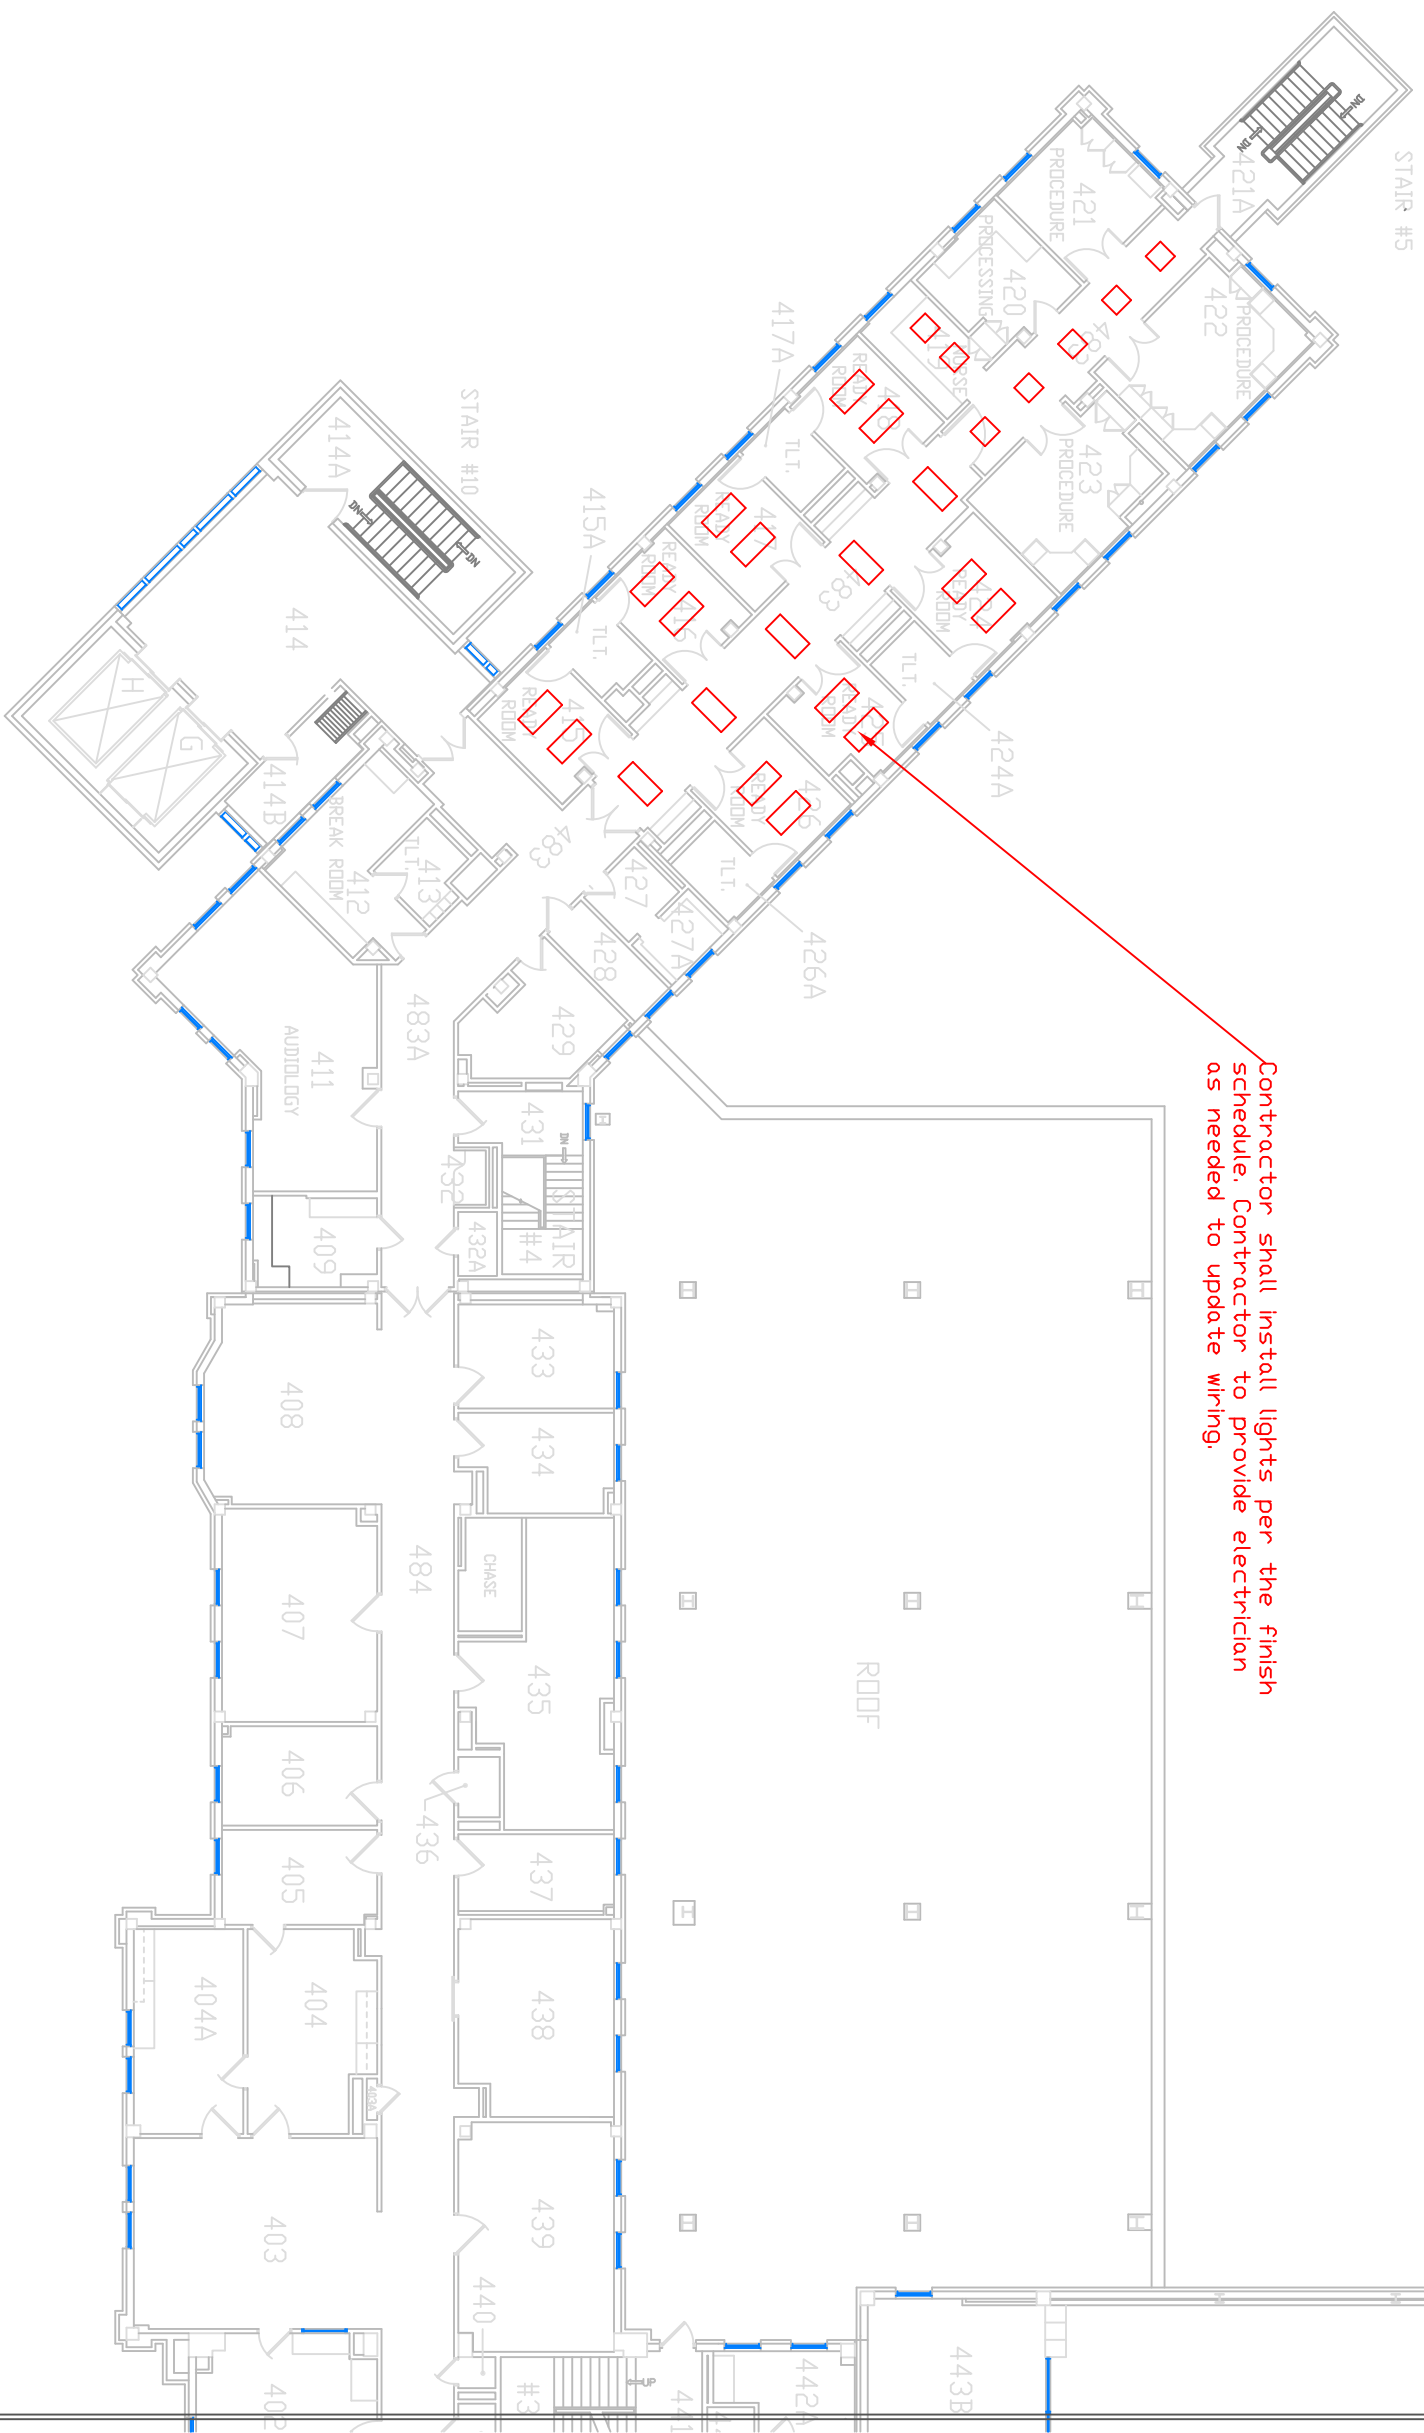

Contractor shall install lights per the finish schedule. Contractor to provide electrician as needed to update wiring.



DRAWING TITLE: ENDD WING - HALLS AND WALLS BUILDING 5 4TH FLOOR	
LOCATION: SIOUX FALLS VA HEALTH CARE SYSTEM SIOUX FALLS, SOUTH DAKOTA	
REVISION:	DATE:

DRAWING NUMBER: 438-22-100 DWG
DRAWN BY: TAW
DATE: 4/12/2022

