


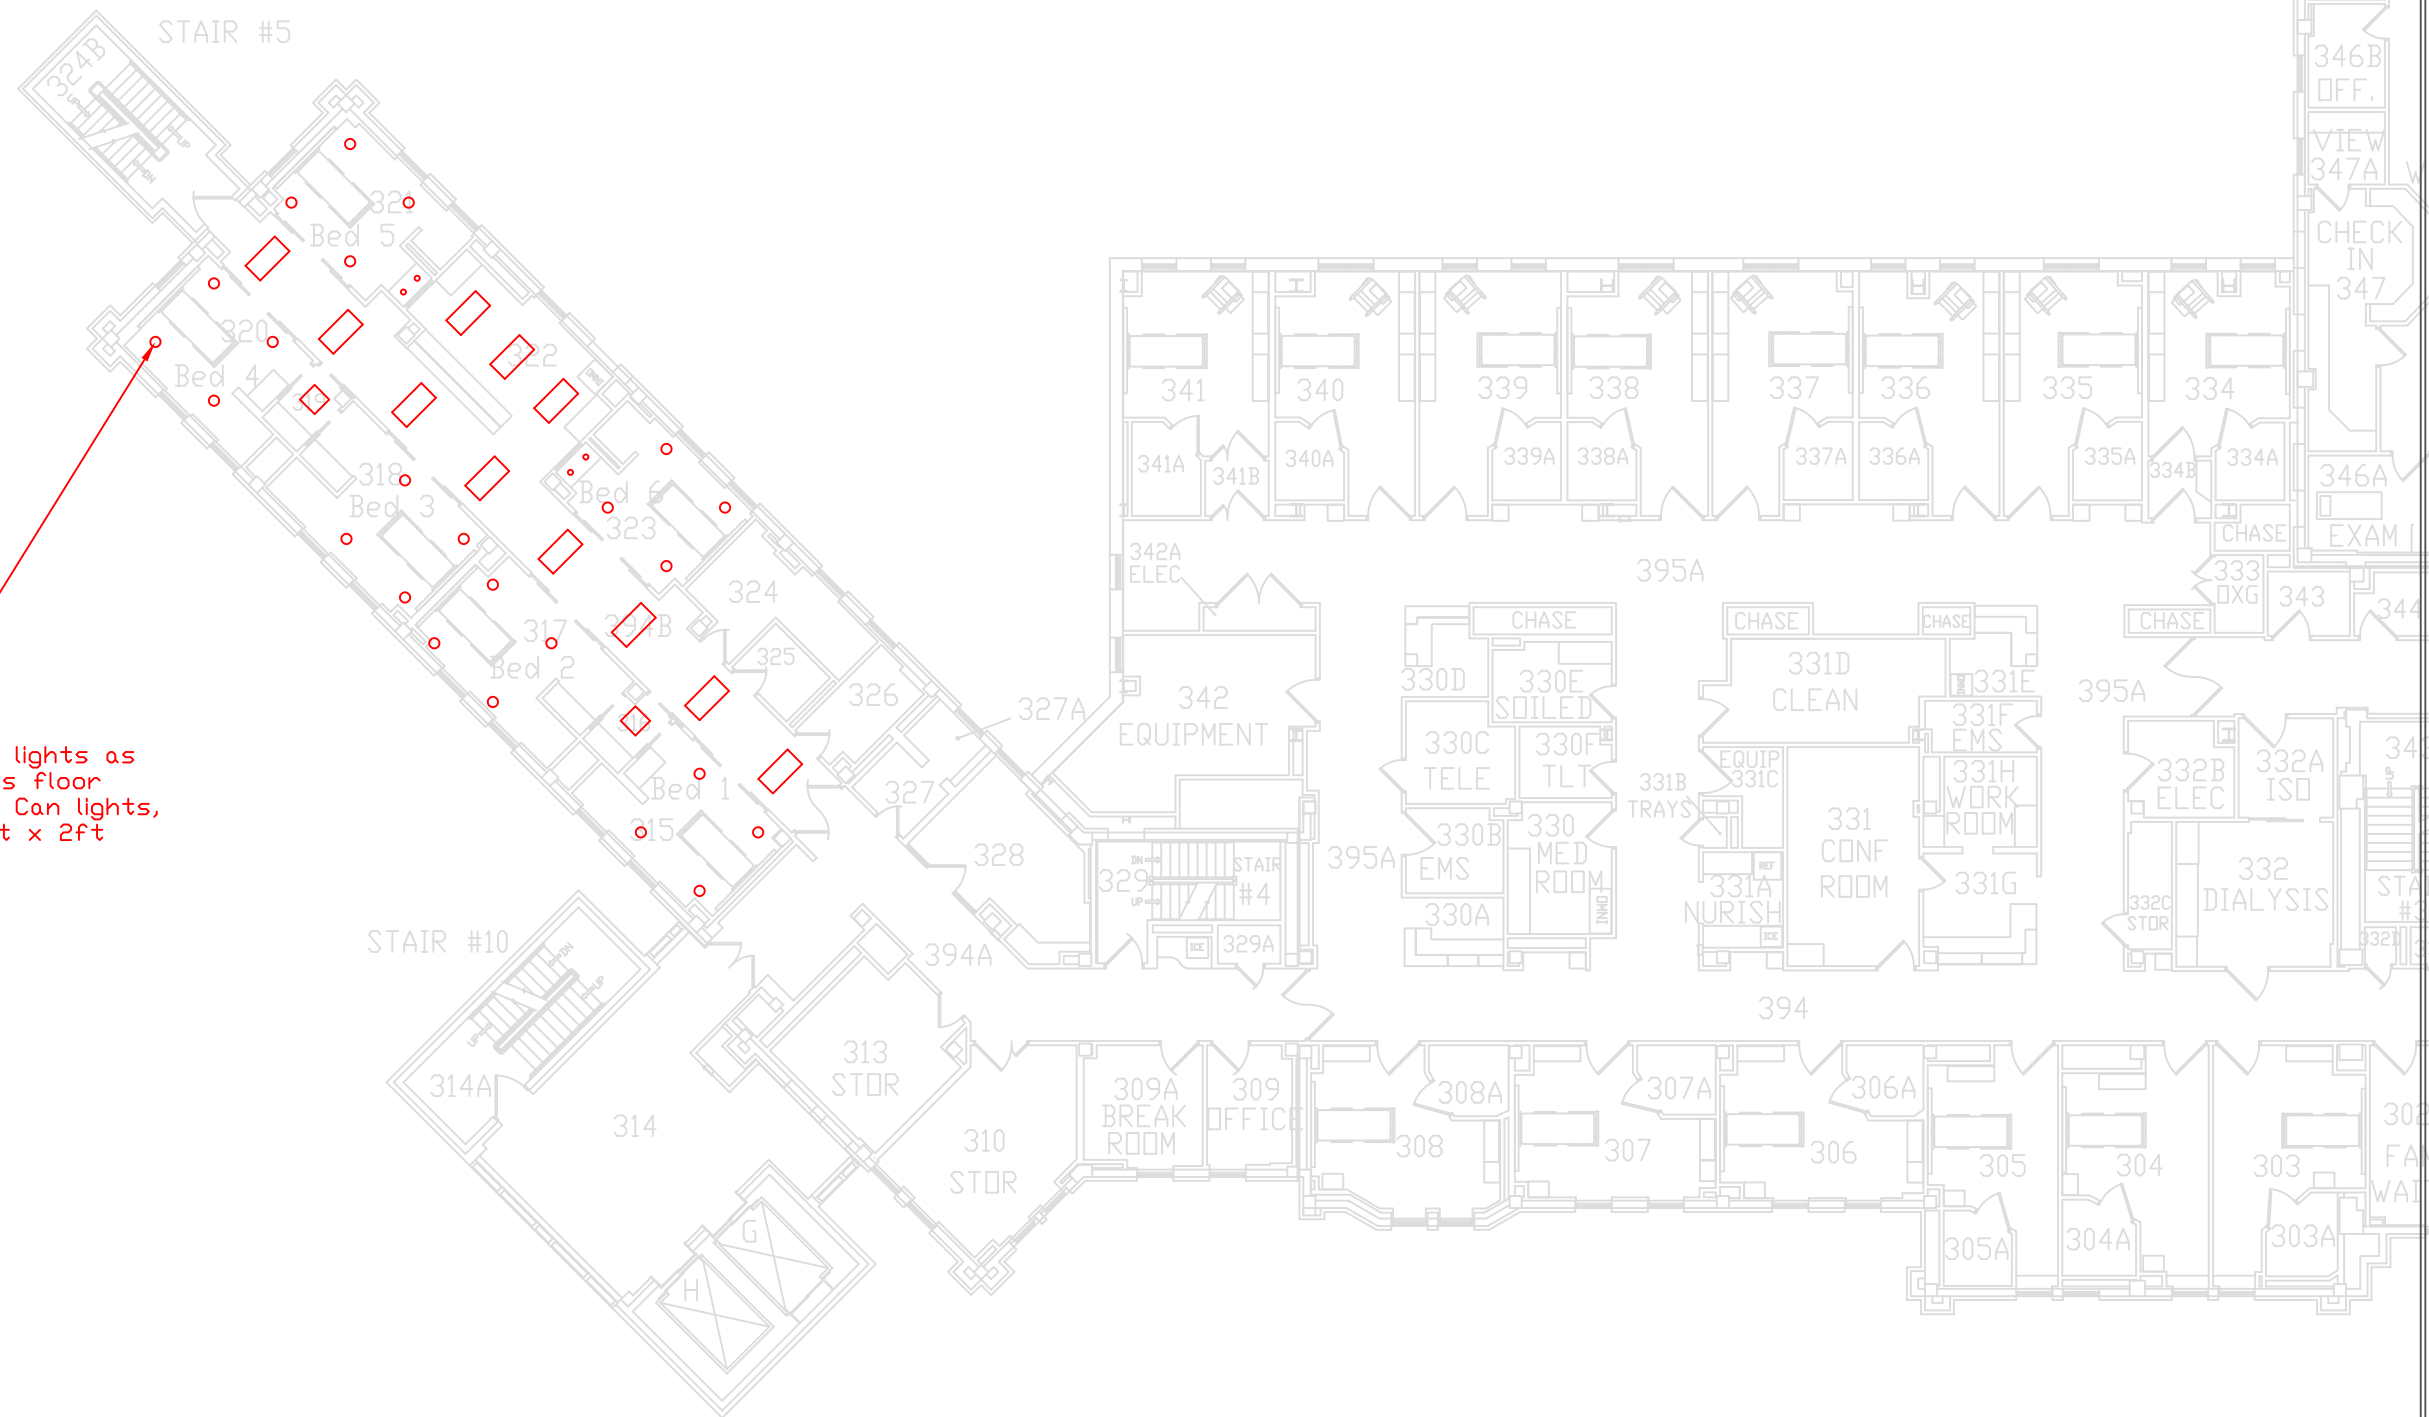

# THIRD FLOOR PLAN

Contractor shall replace lights as prescribed in drawing. This floor includes 6" Can lights, 4" Can lights, and 2ft x 4ft lights, 2ft x 2ft lights.



scale  
feet



DRAWING TITLE: ICU WING - HALLS AND WALLS  
BUILDING 5 3RD FLOOR

DRAWING NUMBER:  
438-22-100  
DWG

LOCATION: SIOUX FALLS VA HEALTH CARE SYSTEM  
SIOUX FALLS, SOUTH DAKOTA

DRAWN BY: TAW

REVISION:

DATE:

DATE: 4/12/2022

