


NOTE: NOT ALL KEYED NOTES MAY BE USED ON EACH PLAN

VA FORM 08-6231

13605 1st Ave. N. #100 Plymouth, MN 55441
P 763.412.4000 | F 763.412.4090 | ae-mn.com
Anderson Engineering of Minnesota, LLC | Proj # 16584


Approved: _____

AE121

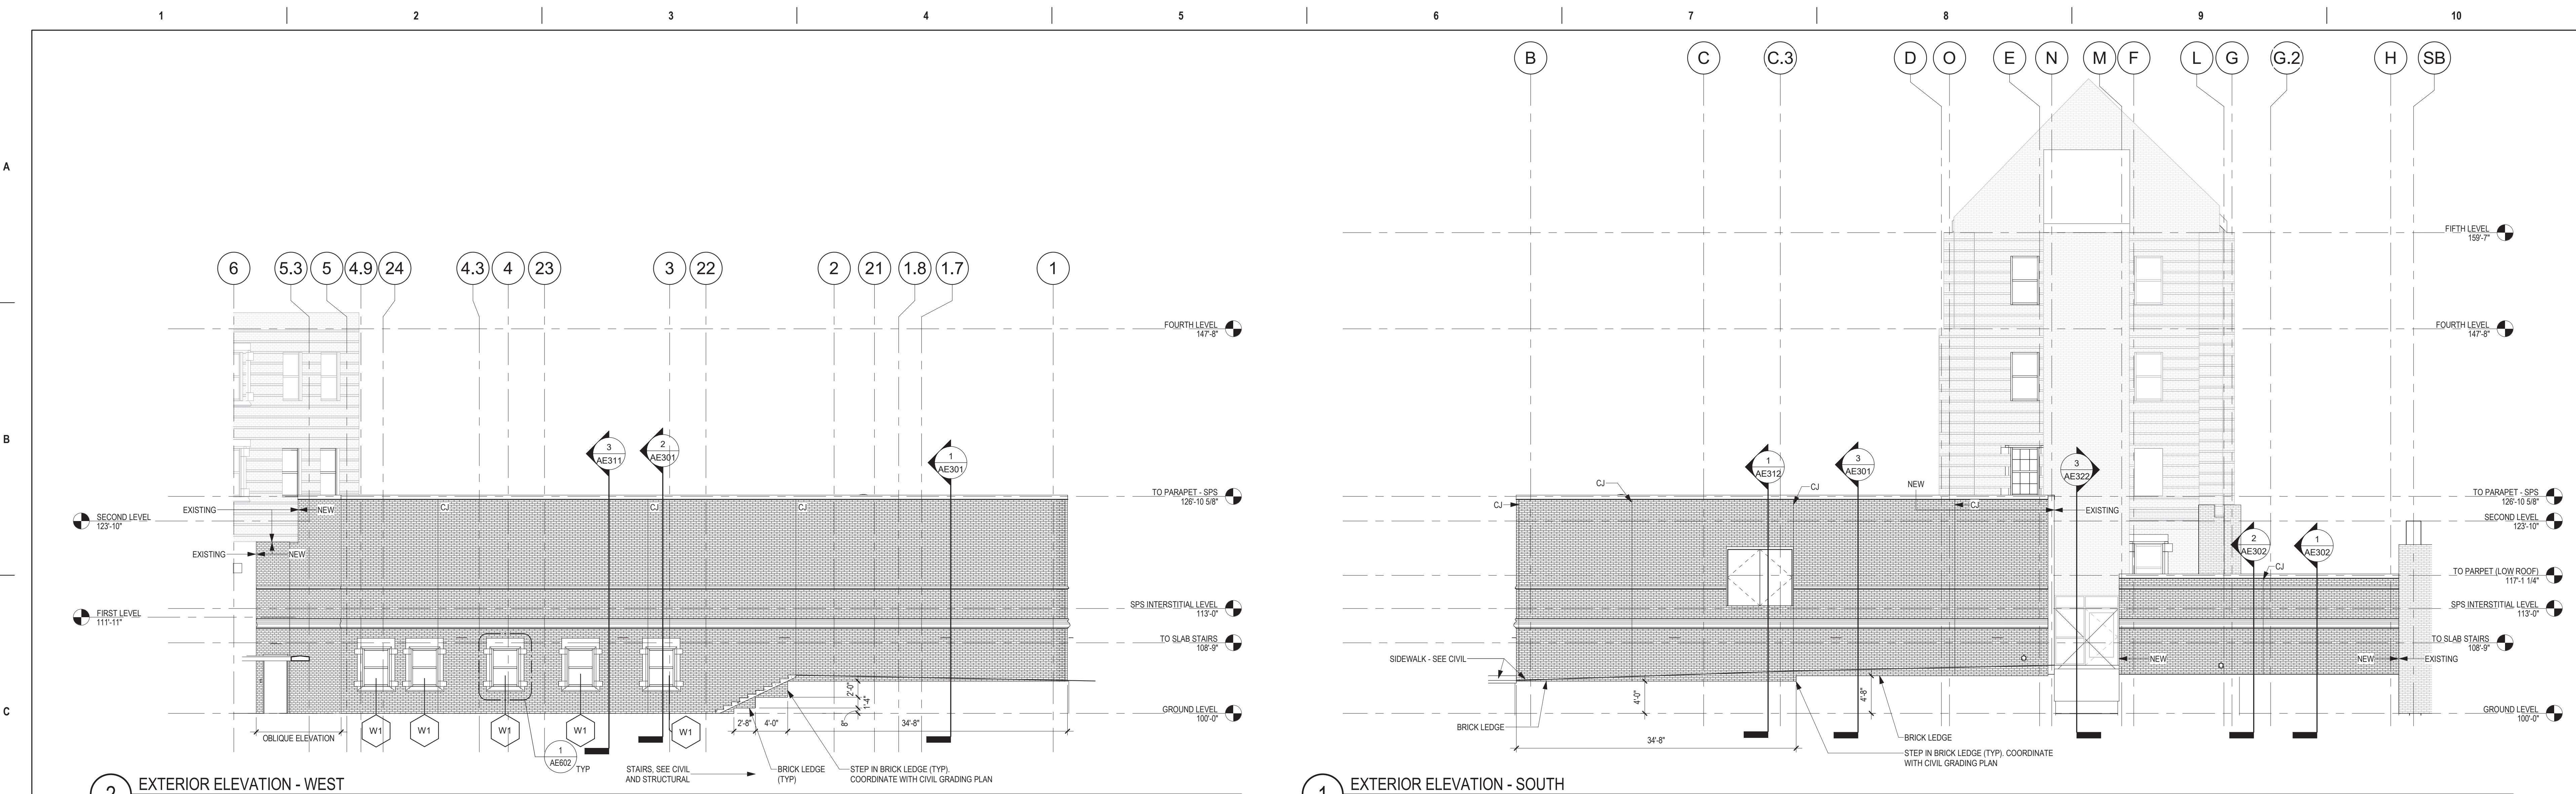


2 EXTERIOR ELEVATION - WEST
1/8" = 1'-0"


1 EXTERIOR ELEVATION - SOUTH
1/8" = 1'-0"

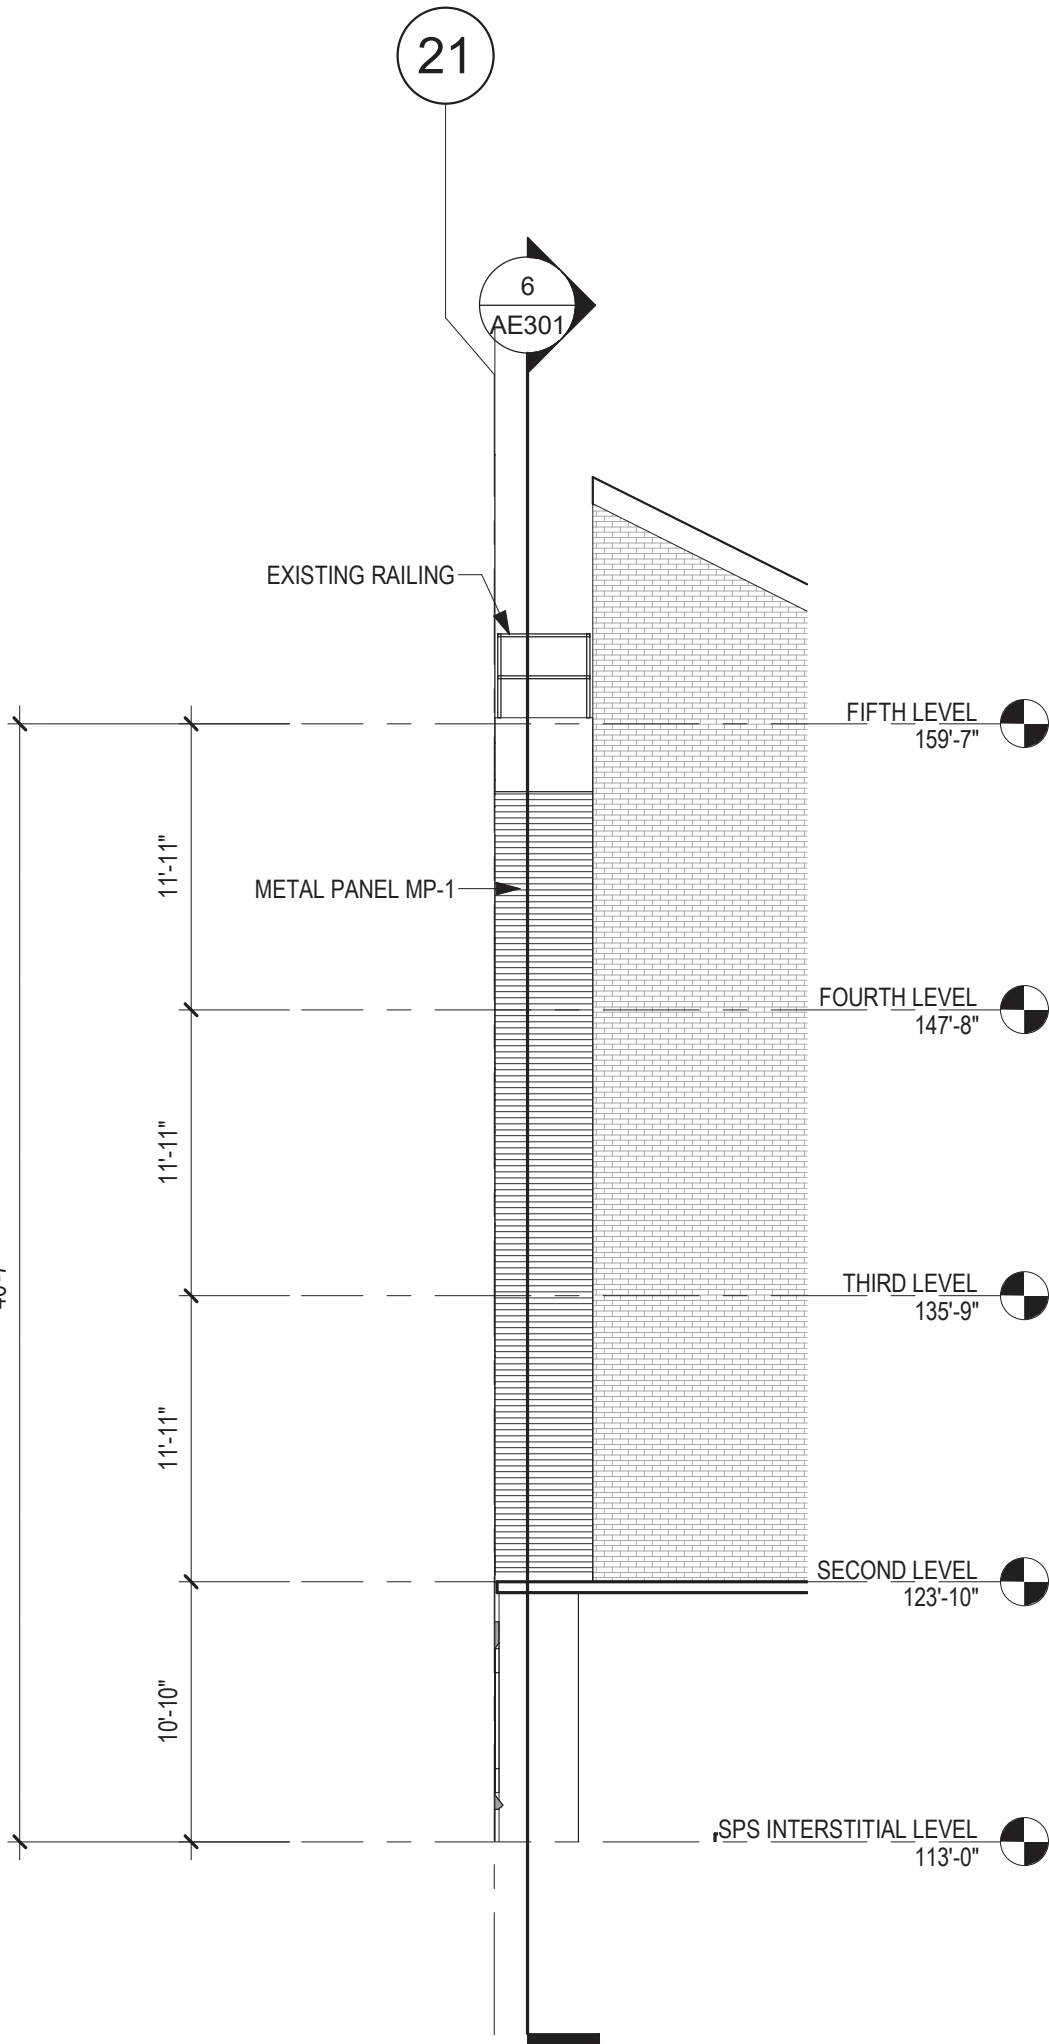


6 EXTERIOR ELEVATION - STAIR TOWER - WEST
1/8" = 1'-0"

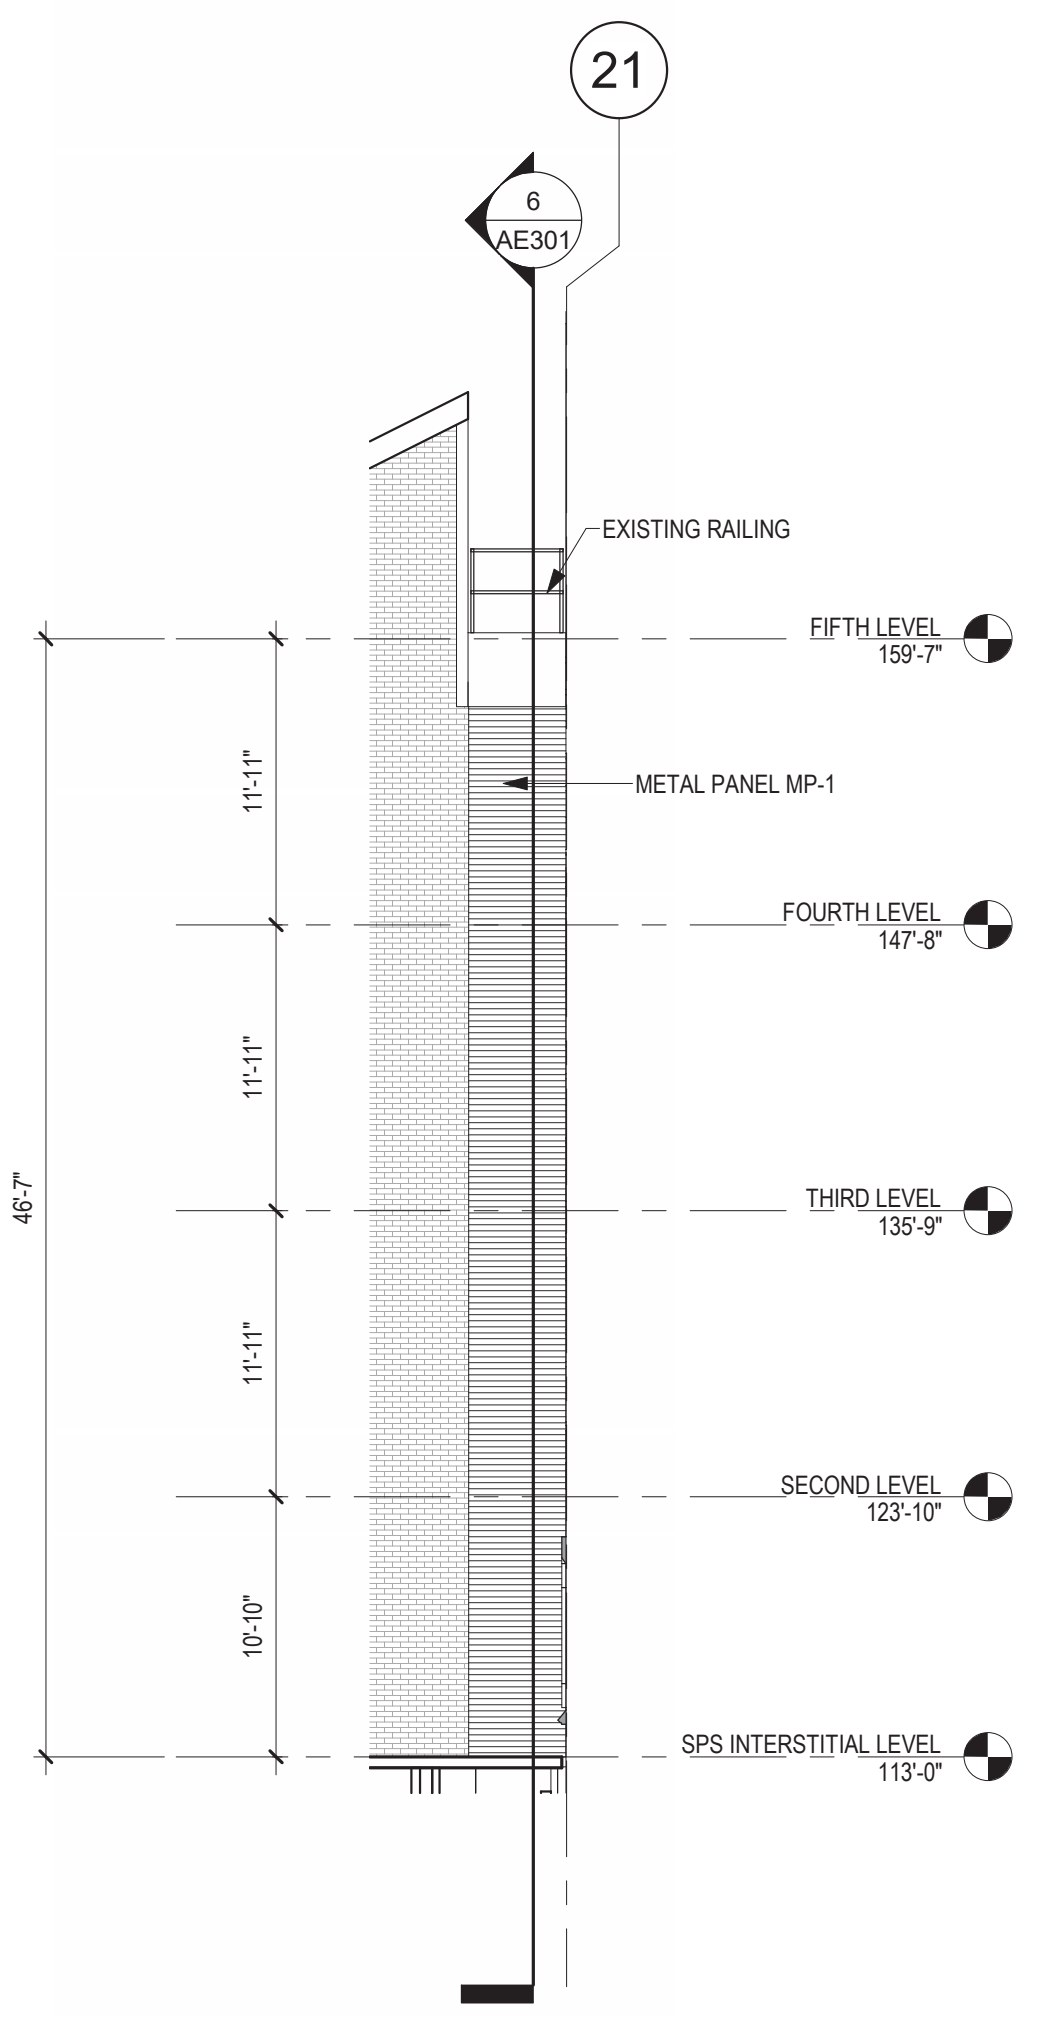


5 EXTERIOR ELEVATION - STAIR TOWER - EAST
1/8" = 1'-0"

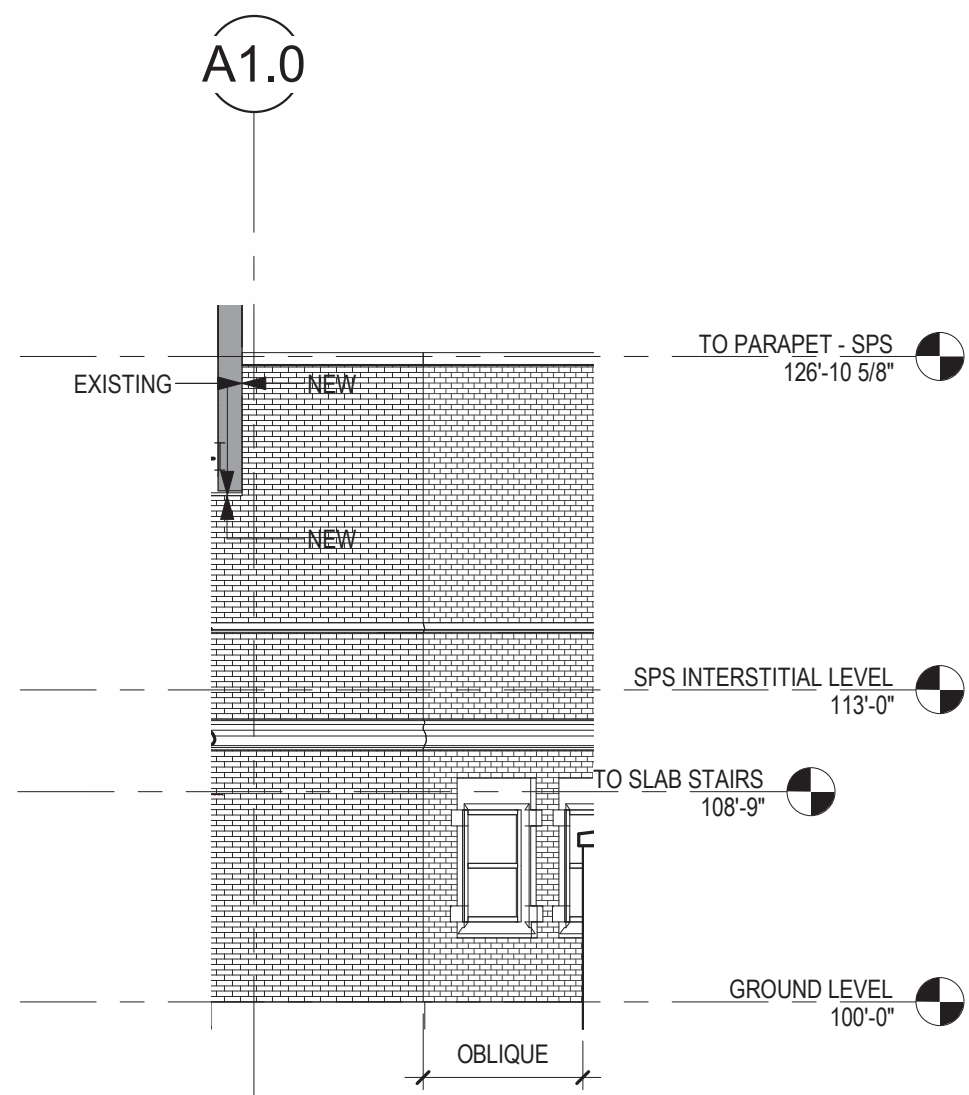

4 PARTIAL EXTERIOR ELEVATION - NORTH
1/8" = 1'-0"

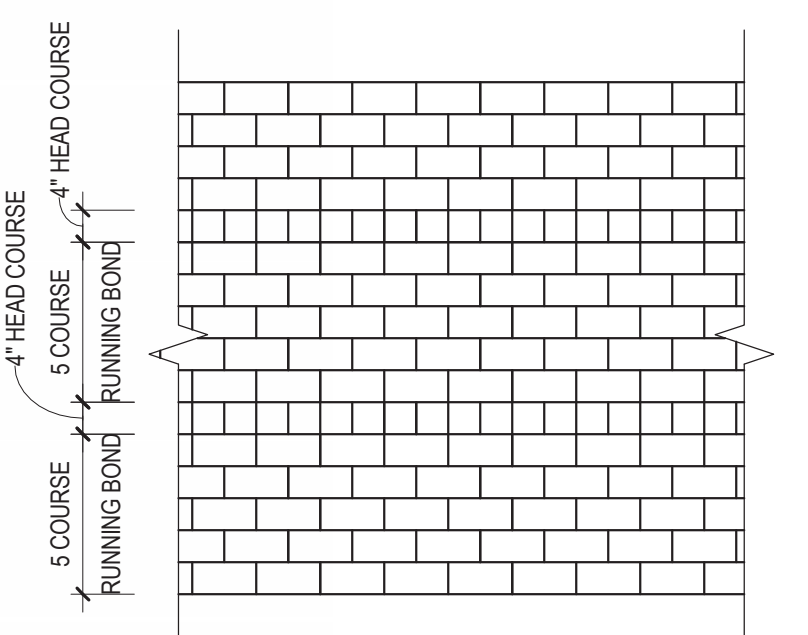


BRICK PATTERN (TYPICAL)

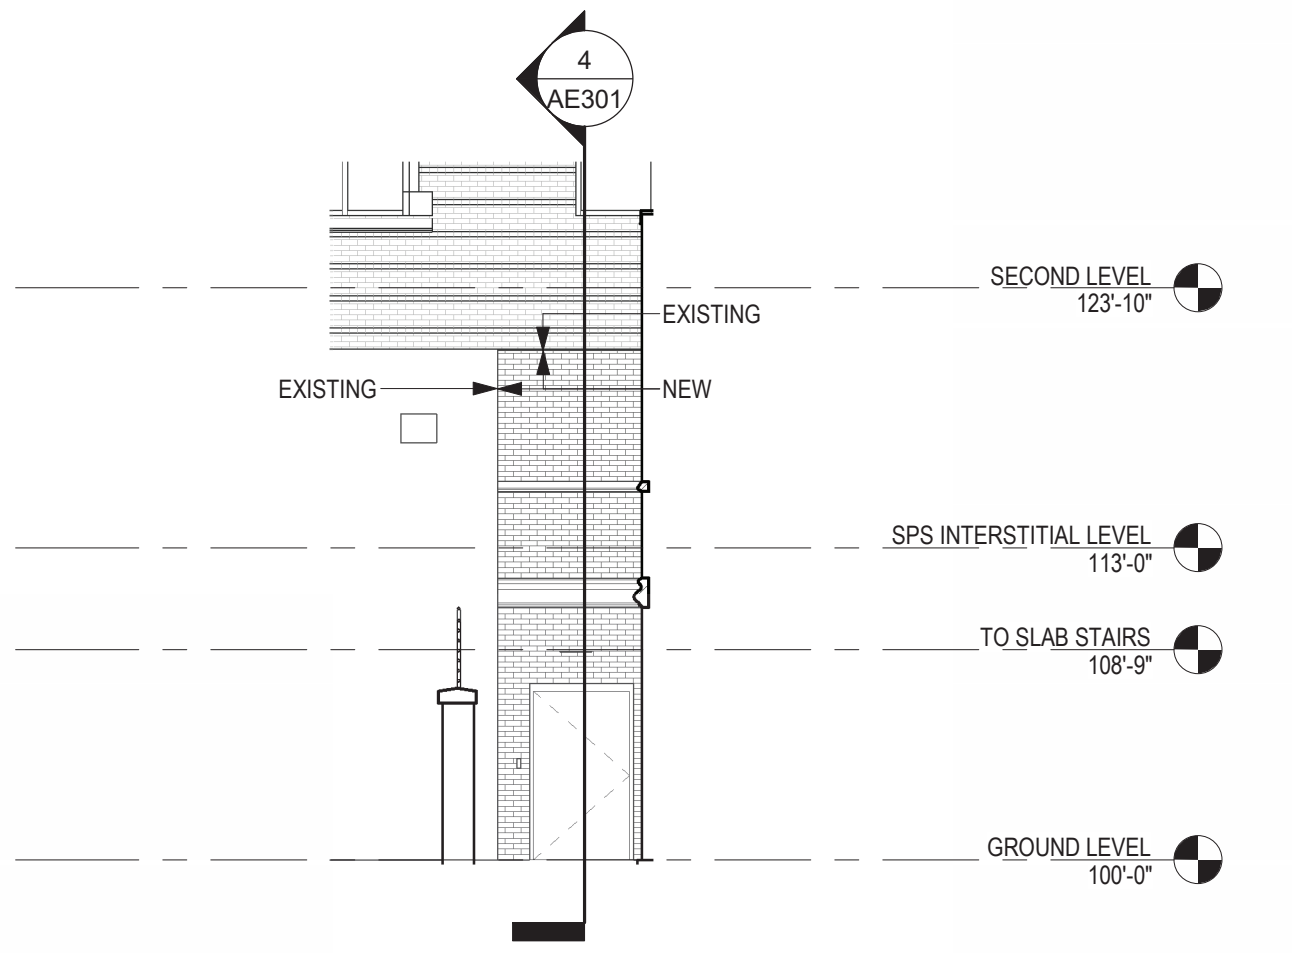

3 PARTIAL EXTERIOR ELEVATION - WEST
1/8" = 1'-0"


Revisions: Date:		CONSULTANT IMEG		ARCHITECT/ENGINEER OF RECORD ANDERSON 13605 1st Ave. N. #100 Plymouth, MN 55441 P 763.412.4000 F 763.412.4090 ae-mn.com Anderson Engineering of Minnesota, LLC Proj # 16584		STAMP DATE: 08/04/2022 License # 9335	Office of Construction and Facilities Management VA U.S. Department of Veterans Affairs	Drawing Title EXTERIOR ELEVATIONS Approved:	Phase BID DOCUMENTS FULLY SPRINKLERED	Project Title CONSTRUCT NEW SPS Location Sioux Falls, SD. Issue Date 08/04/2022 Checked Checker Drawn Author	Project Number 438-460 Building Number 5 Drawing Number AE201
--	--	---------------------------------------	--	--	--	---	---	--	--	--	---

7/7/2023 1:26:48 PM
C:\Users\Public\Documents\Revit Projects\16584-R21_gbarani@ae-mn.com.rvt
VA FORM 08 - 6231

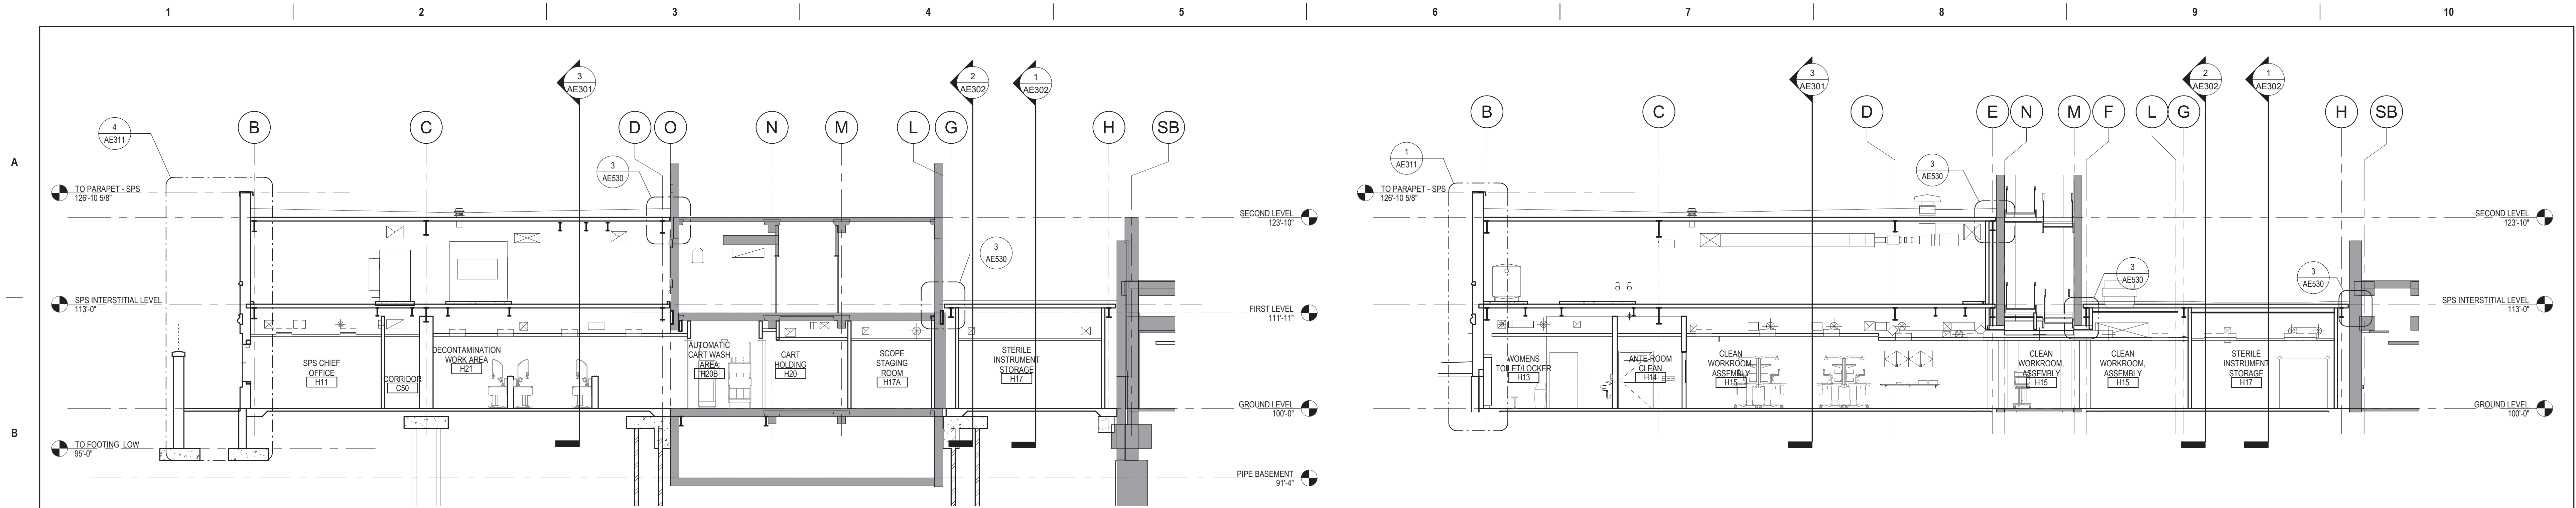


2 BUILDING SECTION - ADDITION AT EXISTING BUILDING 5 - EAST / WEST
1/8" = 1'-0"


1 BUILDING SECTION - ADDITION AT EXISTING STAIR TOWER - EAST / WEST
1/8" = 1'-0"

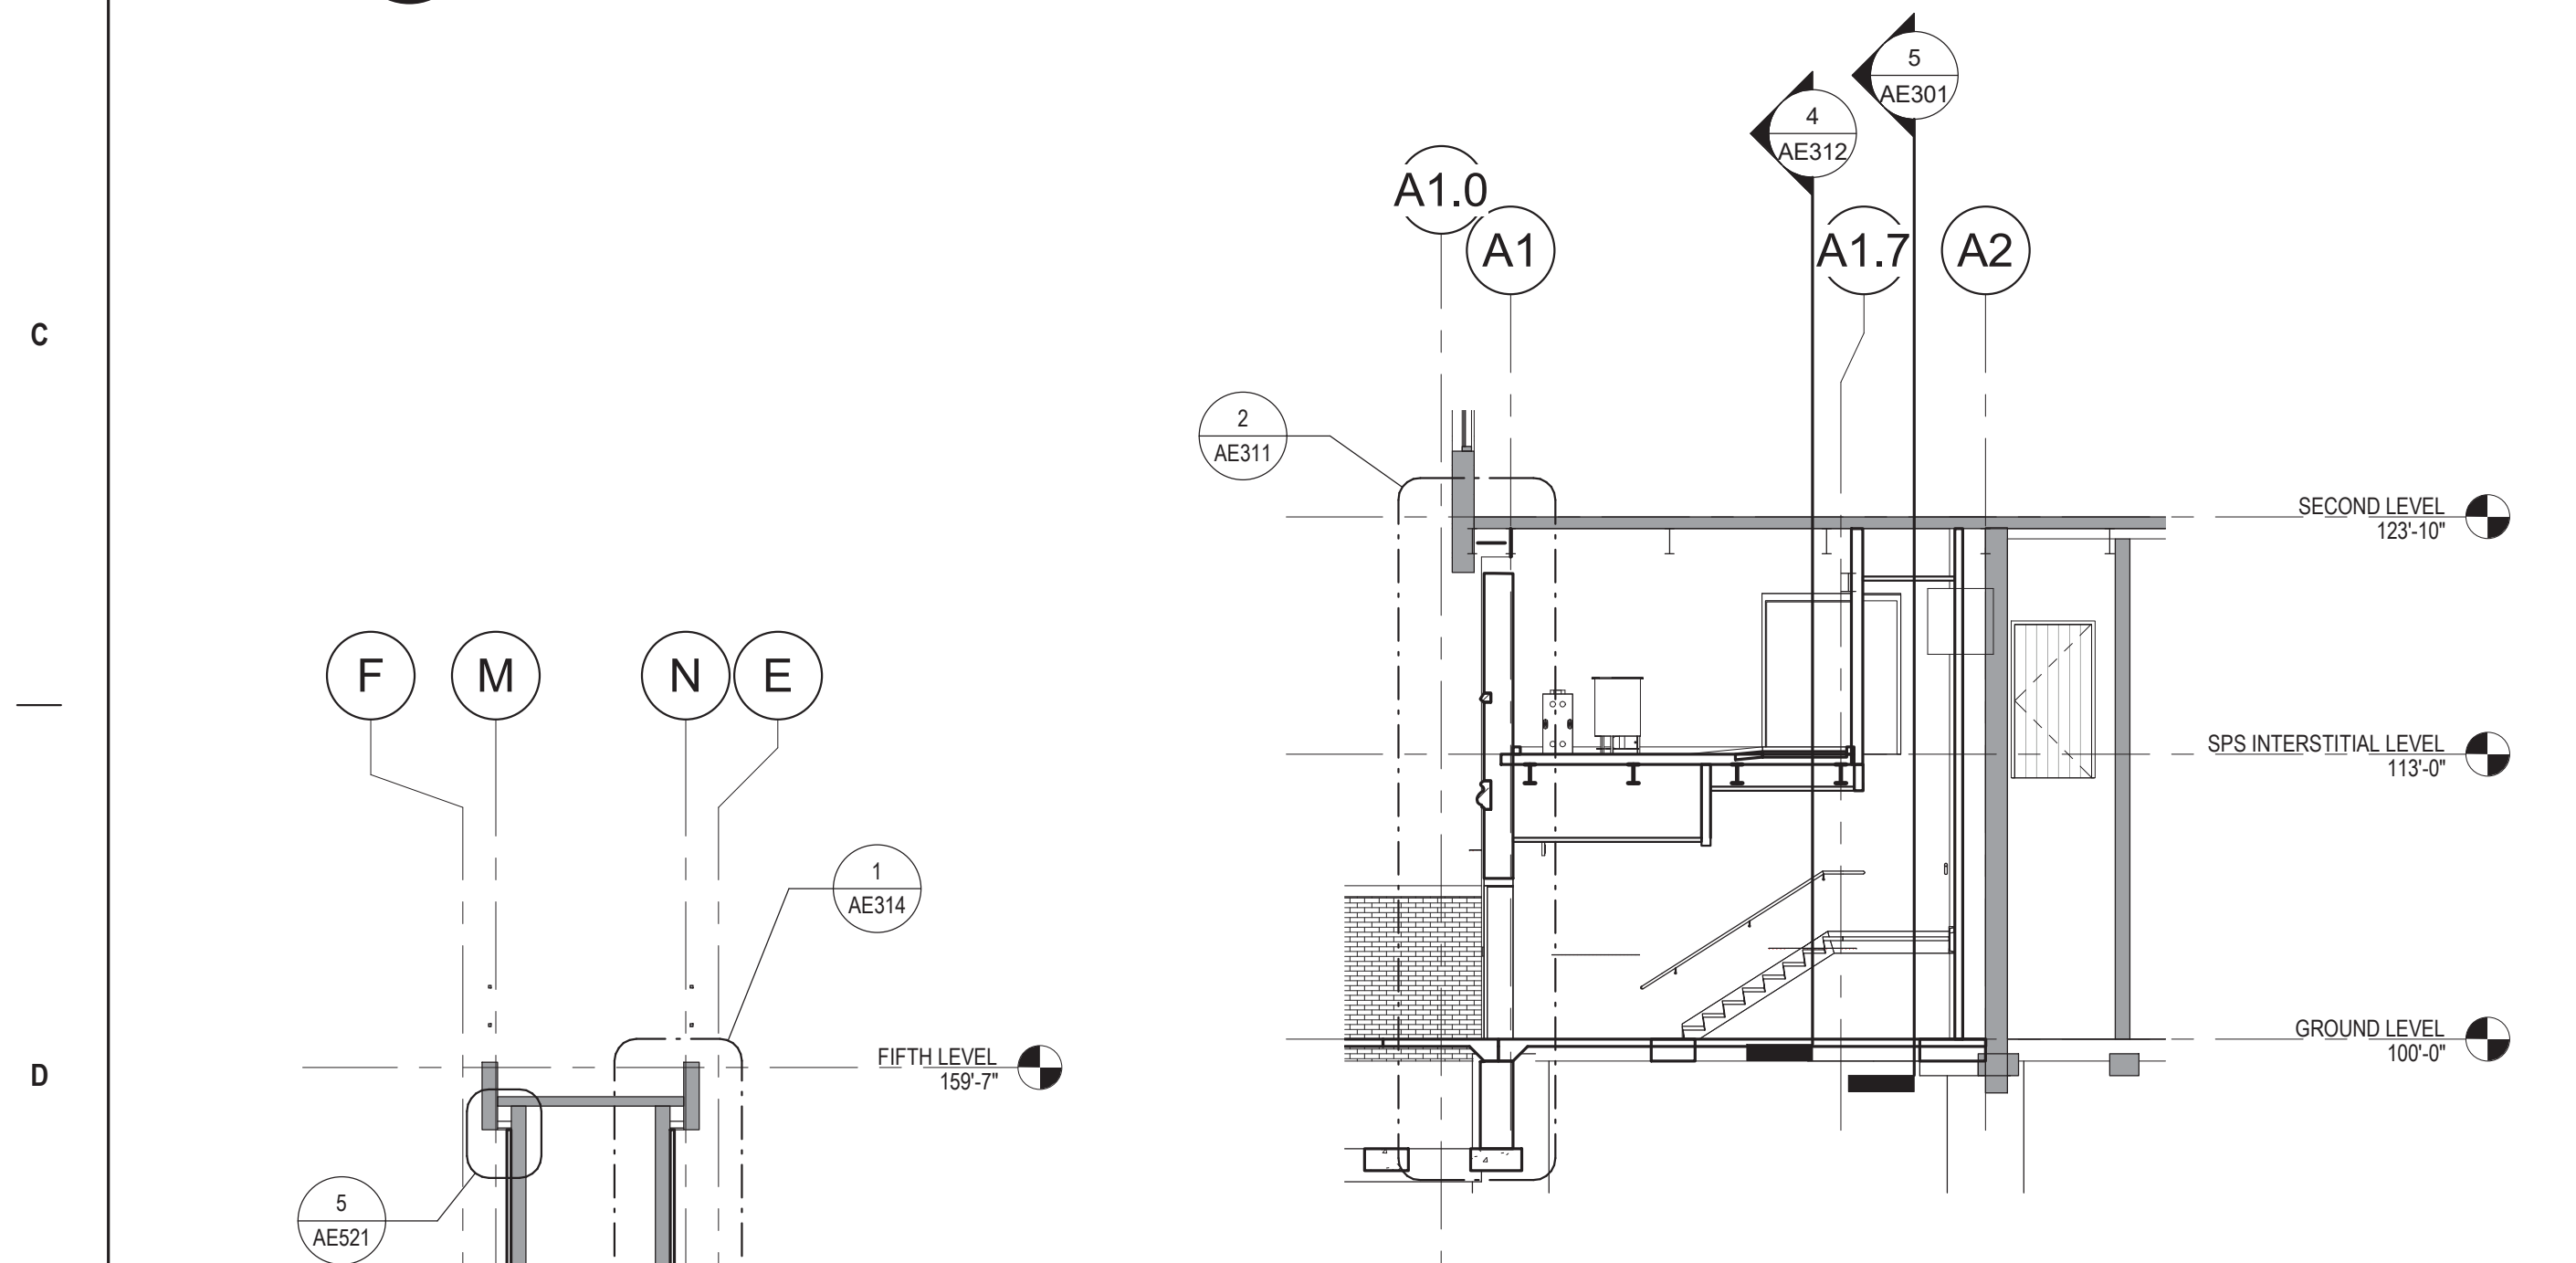


4 BUILDING SECTION - EXIT CORRIDOR @ EXISTING - EAST / WEST
1/8" = 1'-0"

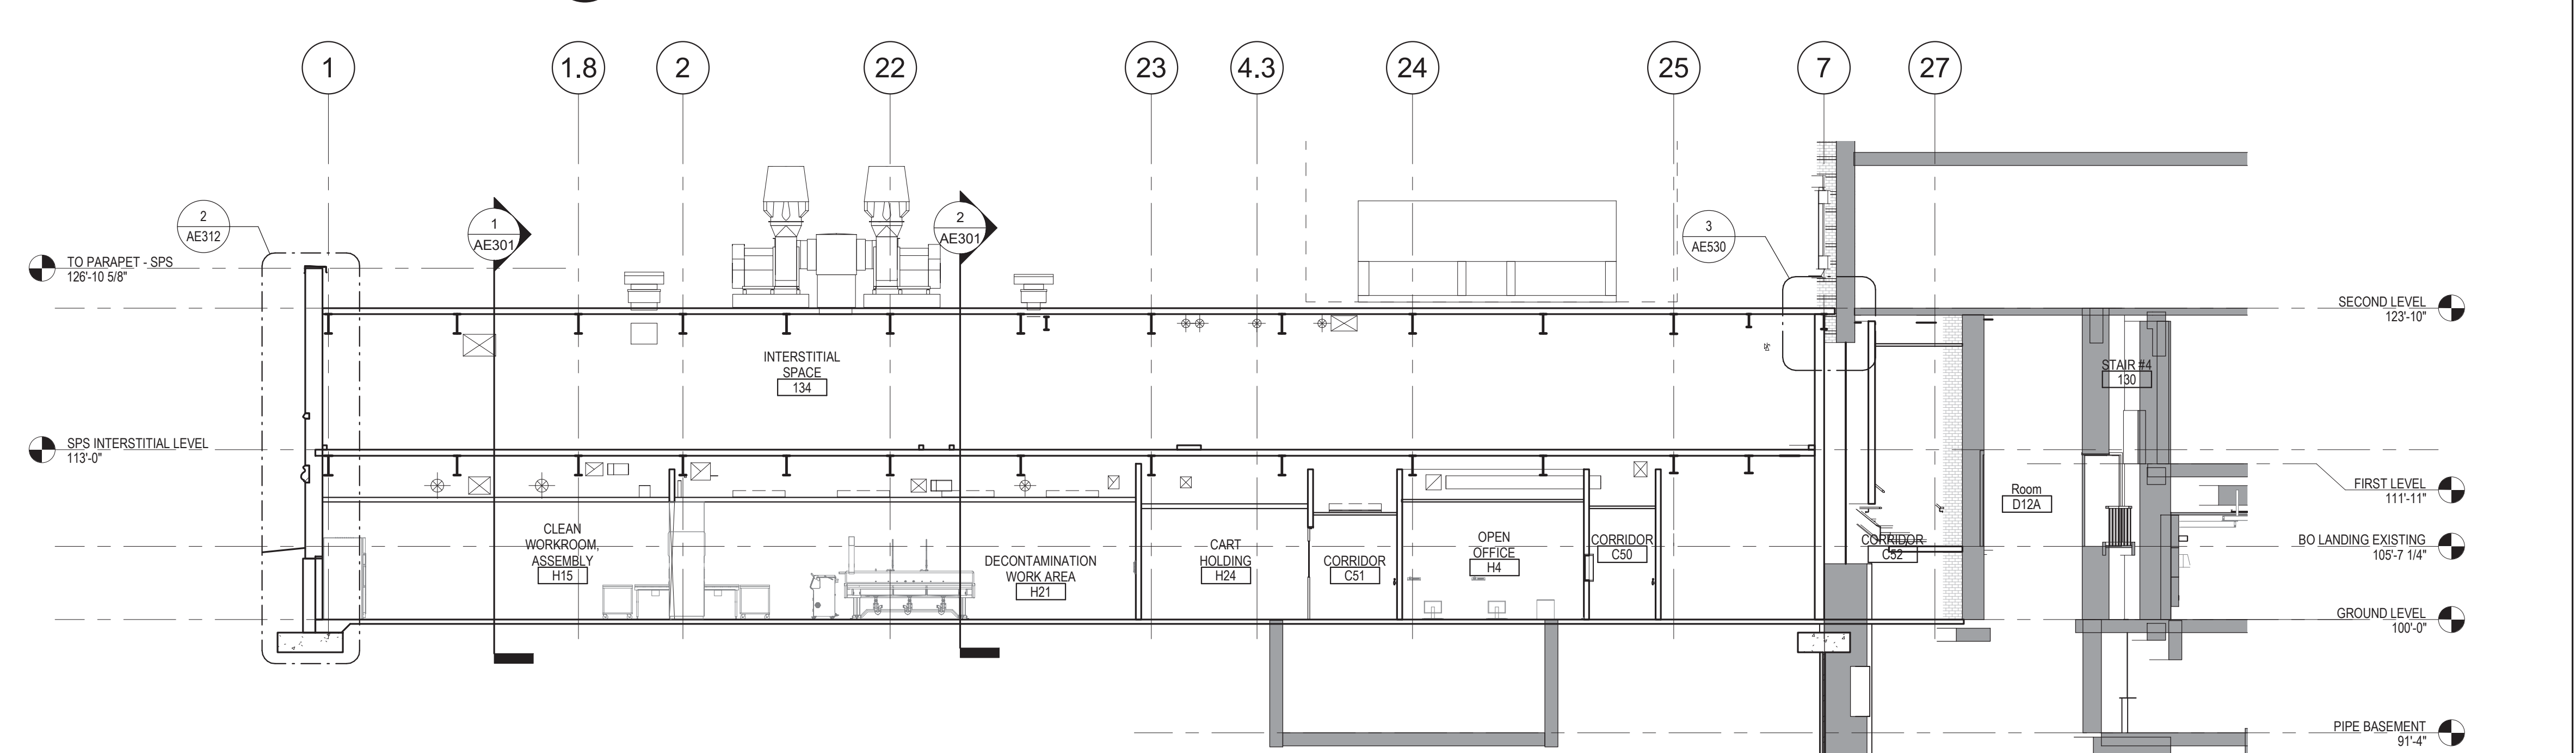

3 BUILDING SECTION - STERILE PROCESSING AND INTERSTITIAL - NORTH / SOUTH
1/8" = 1'-0"

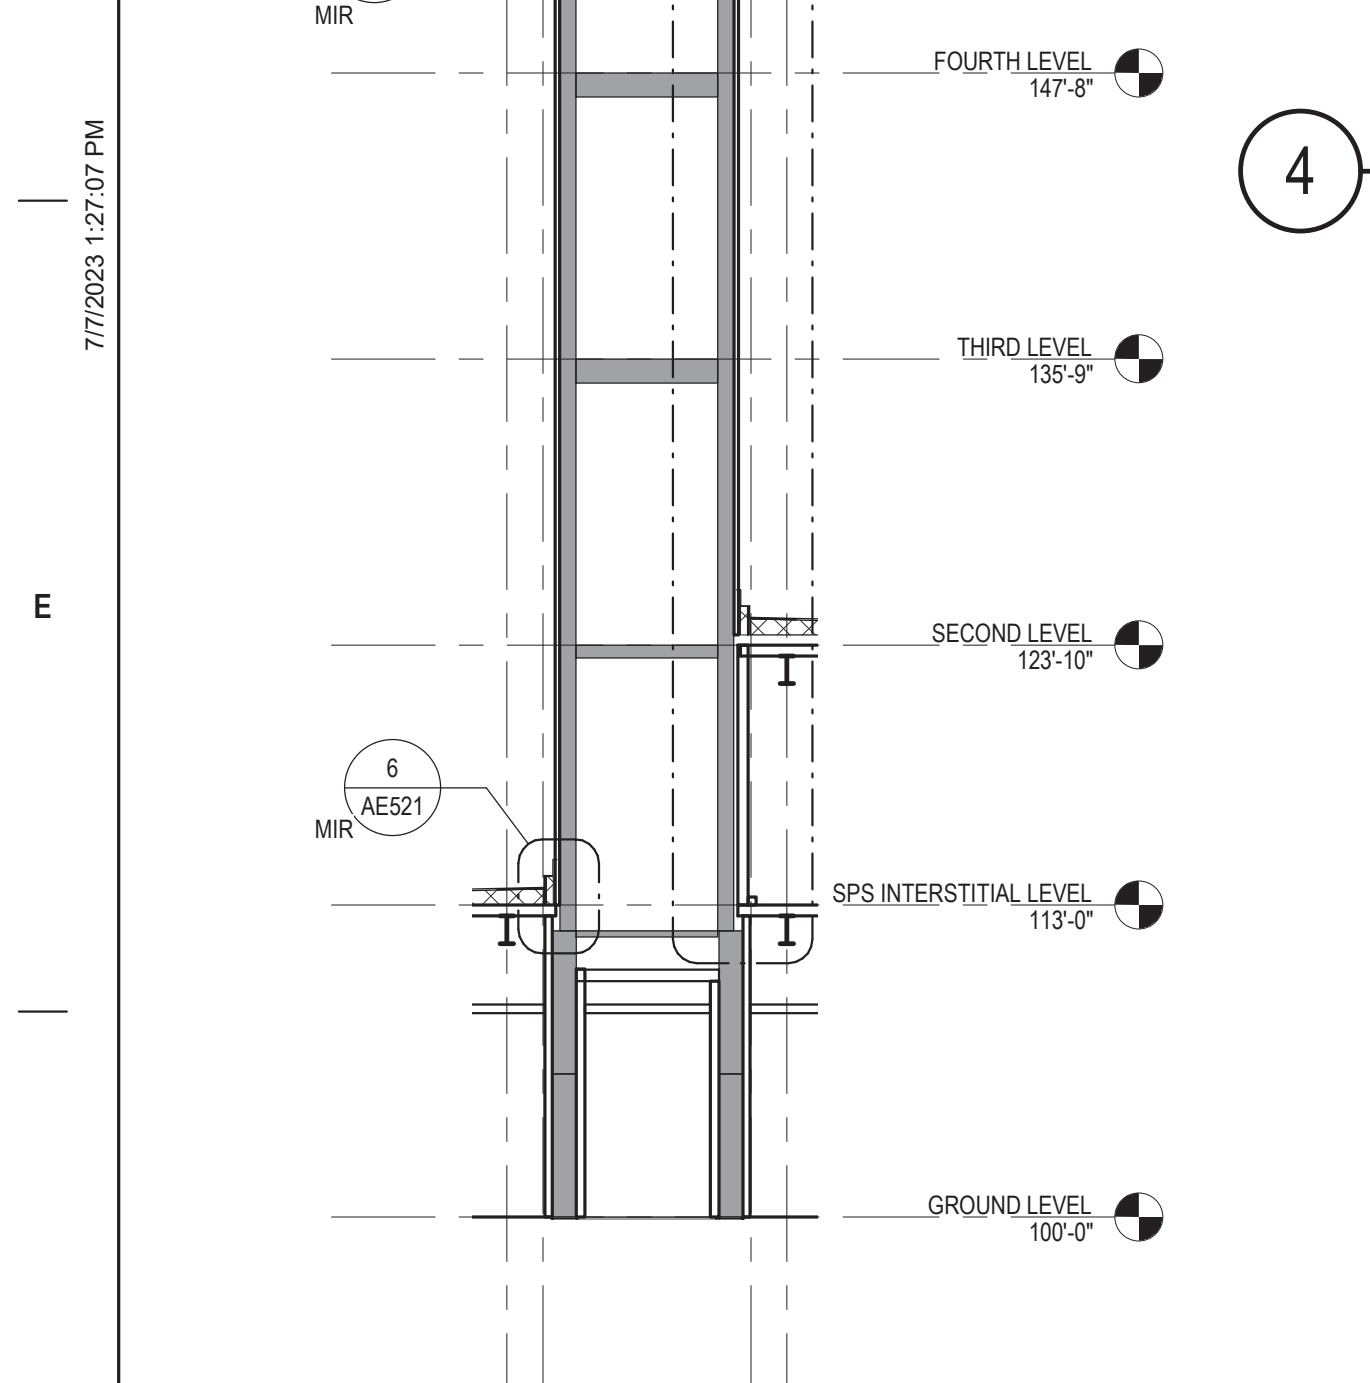

6 SECTION - EXISTING STAIR TOWER - EAST/WEST
1/8" = 1'-0"

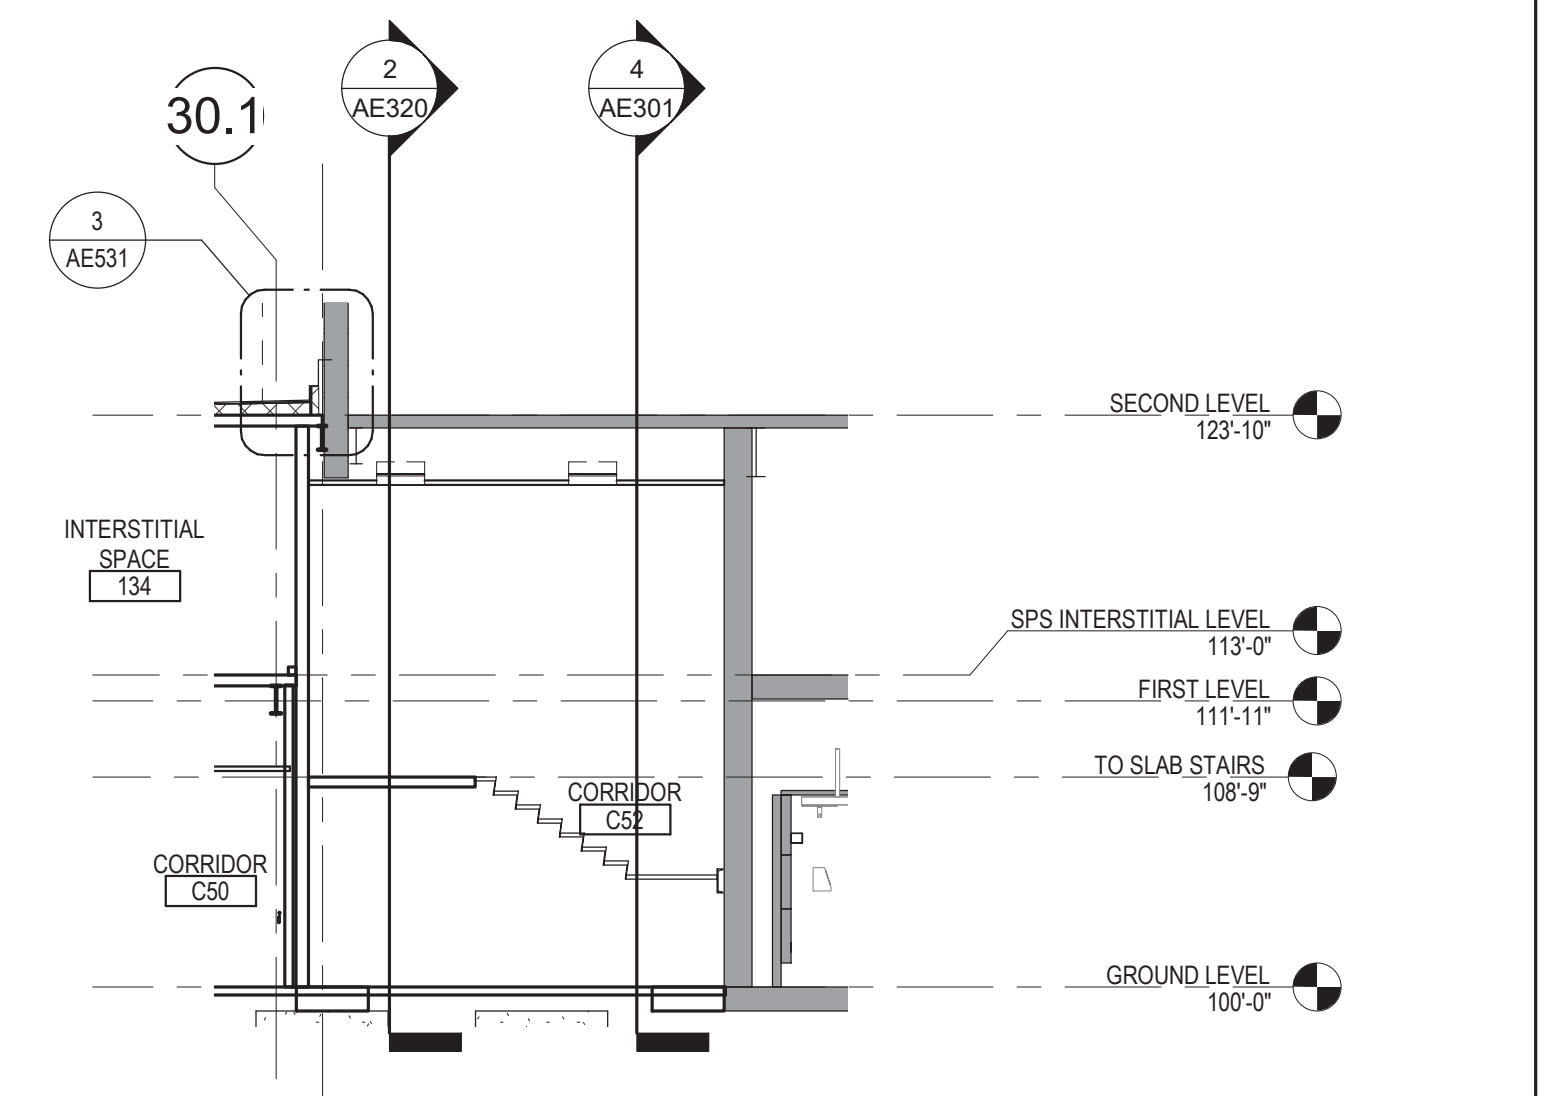

5 BUILDING SECTION - EXIT CORRIDOR @ EXISTING - NORTH / SOUTH
1/8" = 1'-0"

Revisions:	Date:

CONSULTANT

IMEG

ARCHITECT/ENGINEER OF RECORD

ANDERSON

13605 1st Ave. N. #100 Plymouth, MN 55441
P 763.412.4000 | F 763.412.4090 | ae-mn.com
Anderson Engineering of Minnesota, LLC | Proj # 16684

DATE: 08/04/2022
License # 9335

Office of Construction and Facilities Management

U.S. Department of Veterans Affairs

Drawing Title
BUILDING SECTIONS

Approved:

Phase
BID DOCUMENTS

Project Title
CONSTRUCT NEW SPS

Project Number
438-460

Building Number
5

Location
Sioux Falls, SD.

Issue Date
08/04/2022

Checked
Checker

Drawn
Author

Drawing Number
AE301

A

B

C


D

E


F

7/7/2023 1:27:10 PM

C:\Users\Public\Documents\Revit Projects\16584-RCT_gbarani@ae-mn.com.rvt

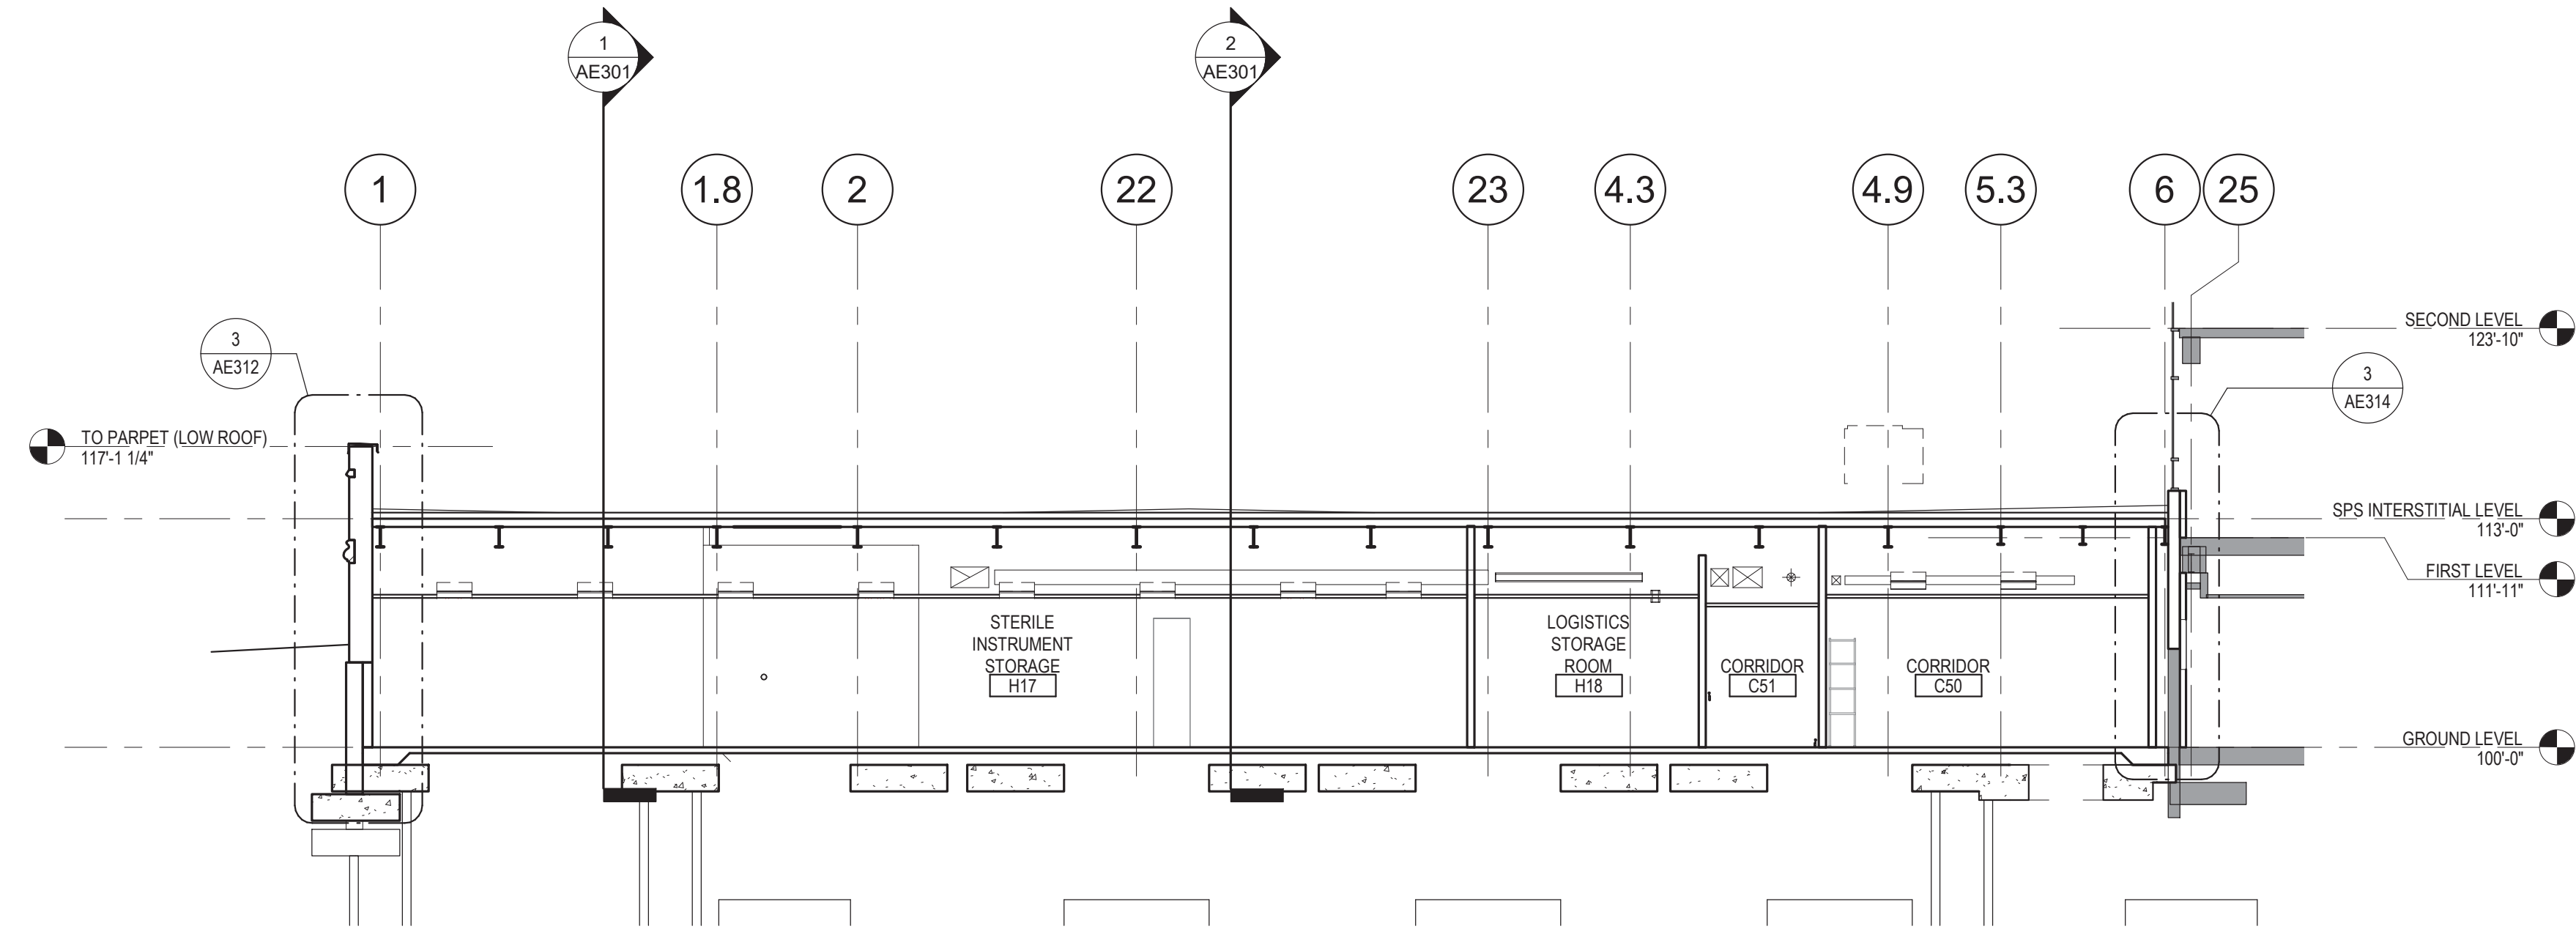

2 BUILDING SECTION - SINGLE STORY ADDITON @ ELEVATOR TOWER LINK - NORTH / SOUTH
1/8" = 1'-0"

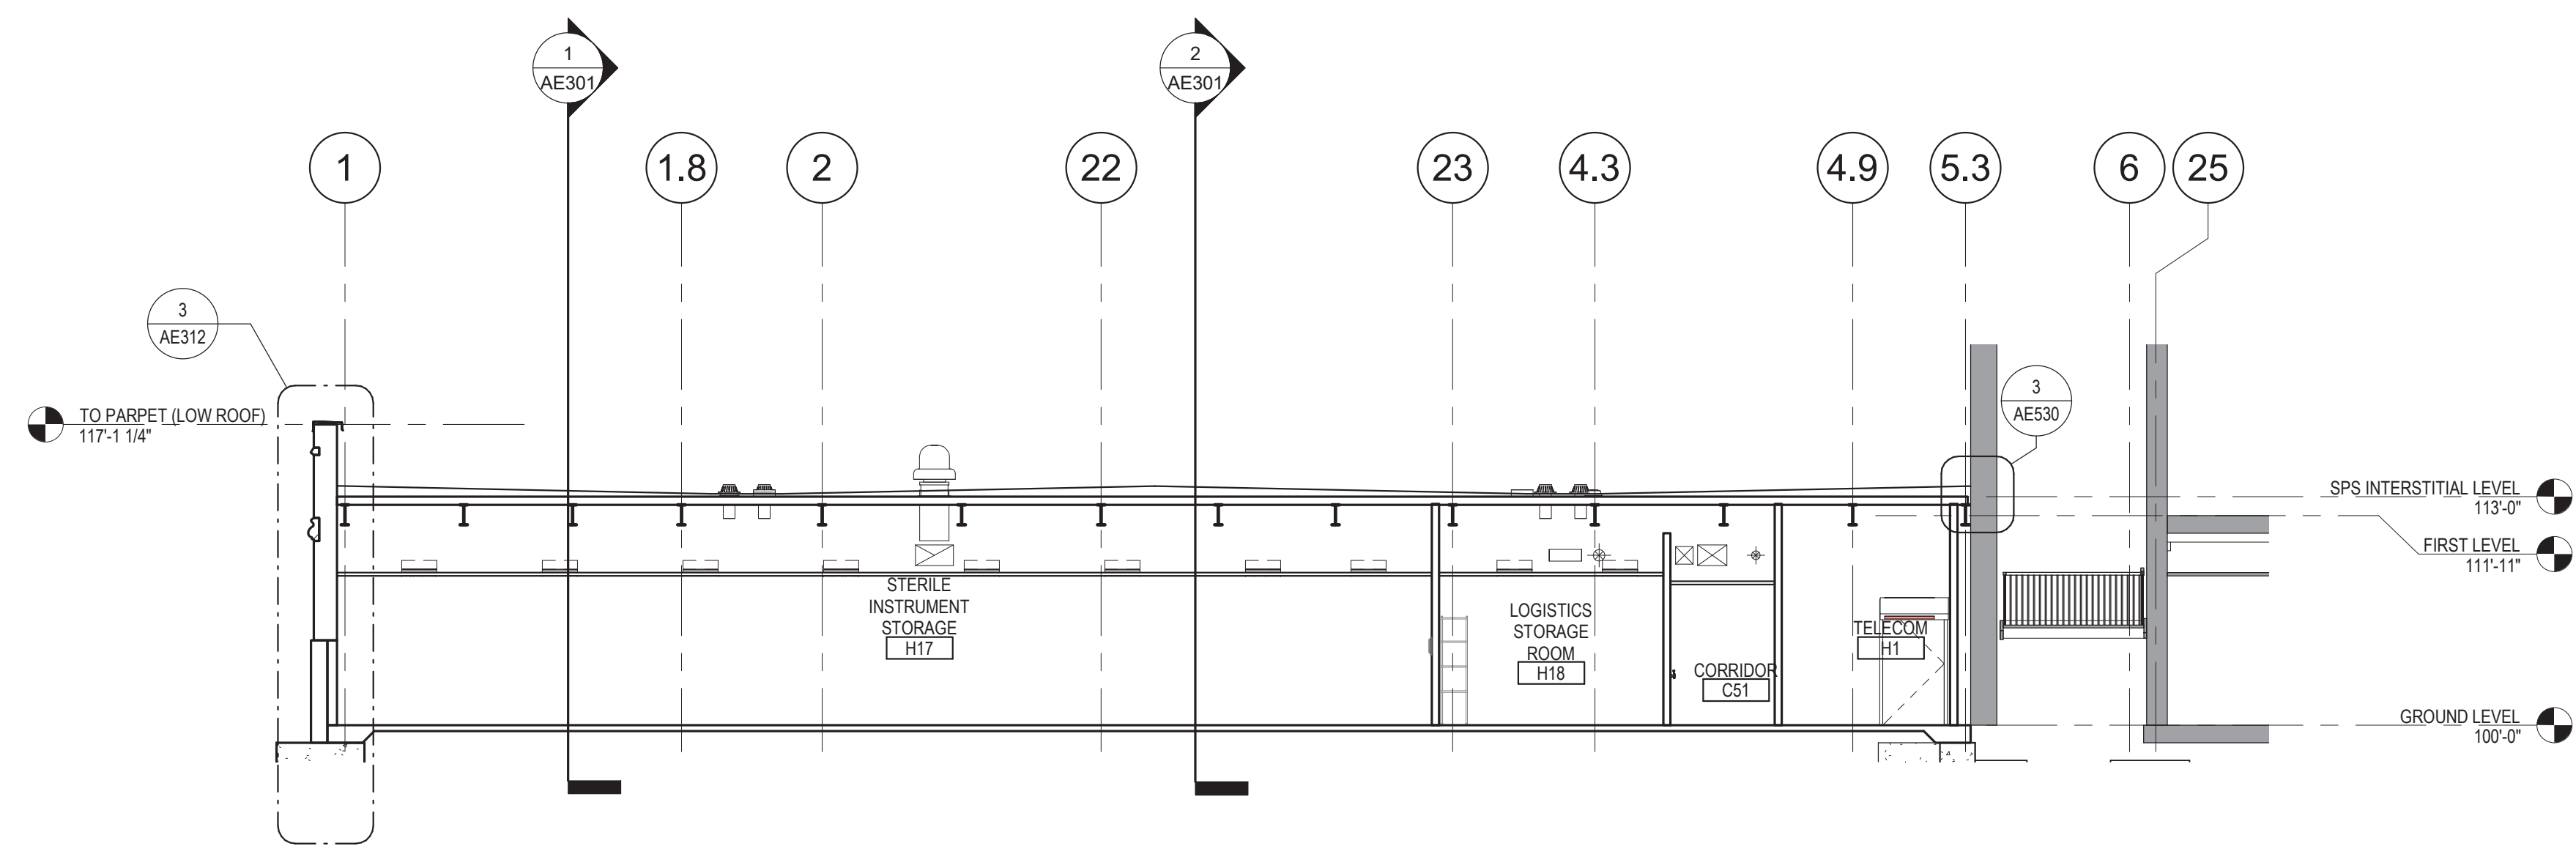

1 BUILDING SECTION - SINGLE STORY / LOW ROOF EAST SIDE - NORTH / SOUTH
1/8" = 1'-0"

A

B

C

D

E

F

Revisions:	Date:

CONSULTANT

ARCHITECT/ENGINEER OF RECORD

13605 1st Ave. N. #100 Plymouth, MN 55441
P 763.412.4000 | F 763.412.4090 | ae-mn.com
Anderson Engineering of Minnesota, LLC | Proj # 16584

STAMP

Office of
Construction
and Facilities
Management

U.S. Department
of Veterans
Affairs

Drawing Title

BUILDING SECTIONS

Approved:

Phase

BID DOCUMENTS

FULLY SPRINKLERED

Project Title

CONSTRUCT NEW SPS

Location

Sioux Falls, SD.

Issue Date

08/04/2022

Checked

Checker

Drawn

Author

Project Number


438-460

Building Number

5

Drawing Number

AE302

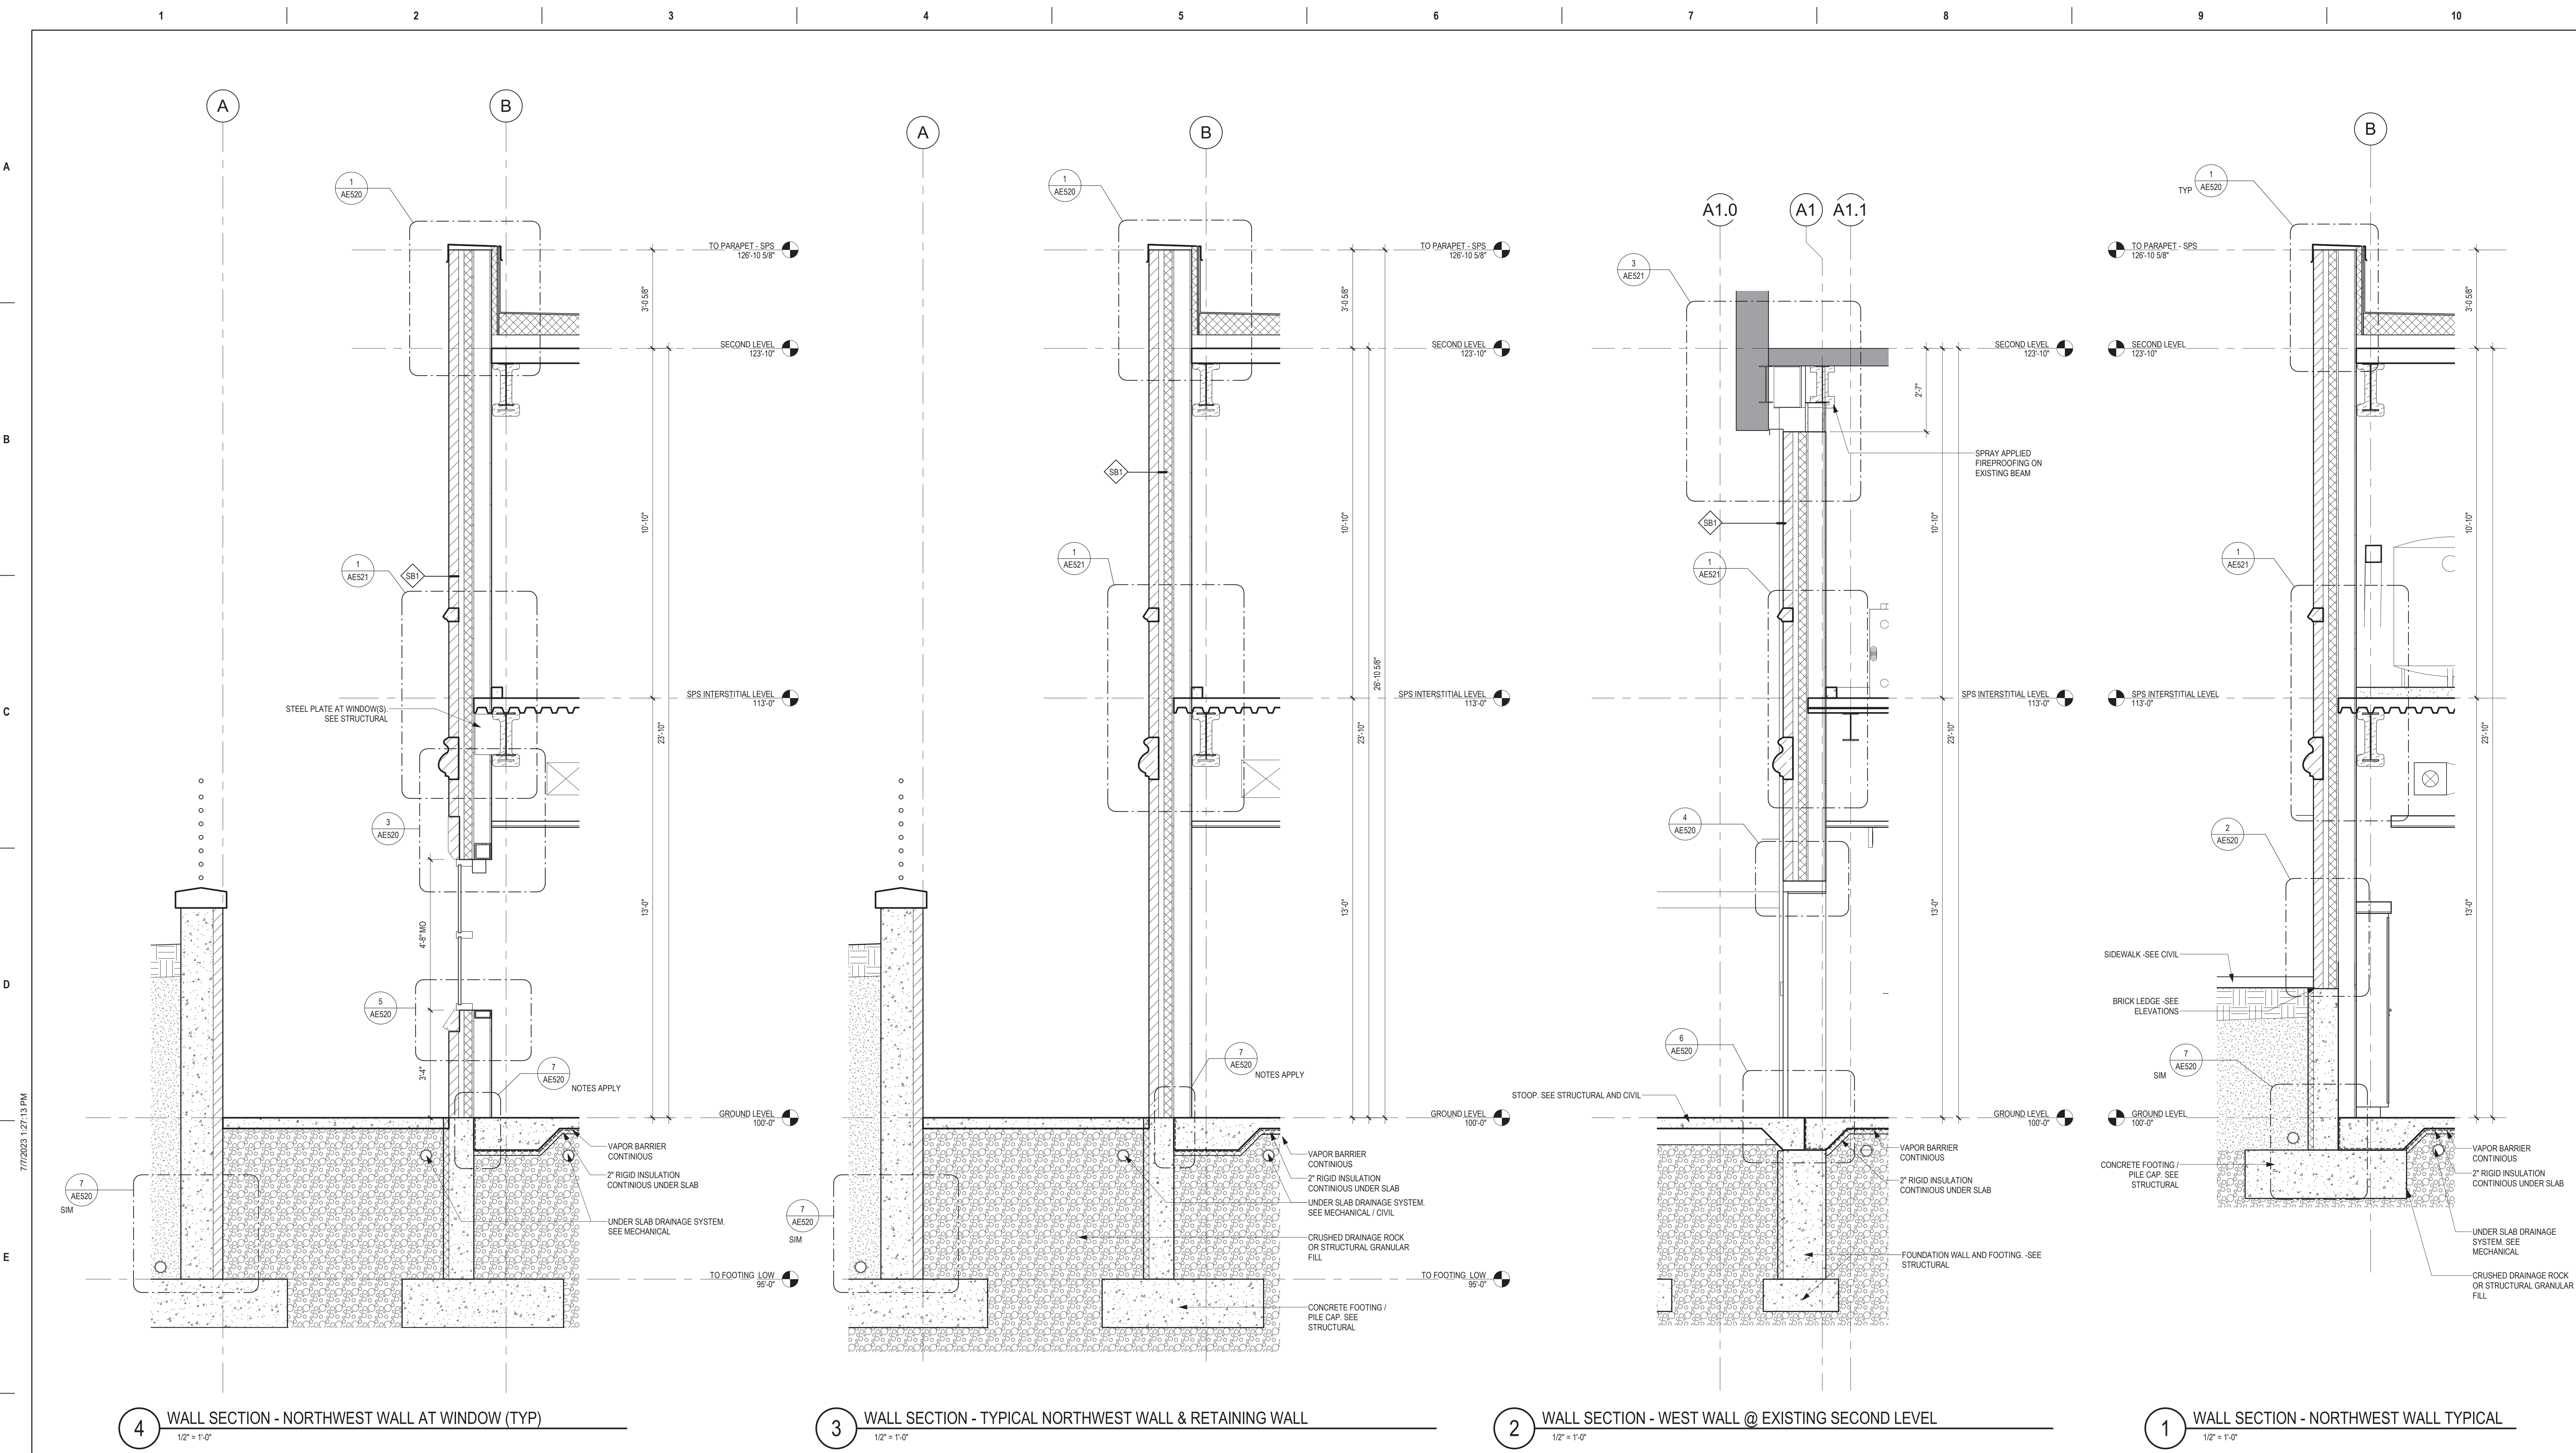

7/7/2023 1:27:13 PM
C:\Users\Public\Documents\Revit Projects\16554-RCT_gharani@ae-mn.com.rvt

Revisions:	Date:

CONSULTANT

IMEG

ARCHITECT/ENGINEER OF RECORD

ANDERSON

13605 1st Ave. N. #100 Plymouth, MN 55441
P 763.412.4000 | F 763.412.4090 | ae-mn.com
Anderson Engineering of Minnesota, LLC | Proj # 16584

DATE: 08/04/2022
License # 9335

Office of
Construction
and Facilities
Management

VA U.S. Department
of Veterans
Affairs

Drawing Title
WALL SECTIONS

Approved:

Phase
BID DOCUMENTS

FULLY SPRINKLERED

Project Title
CONSTRUCT NEW SPS

Location
Sioux Falls, SD.

Issue Date
08/04/2022


Checked
Checker

Drawn
Author

Project Number
438-460

Building Number
5

Drawing Number
AE311

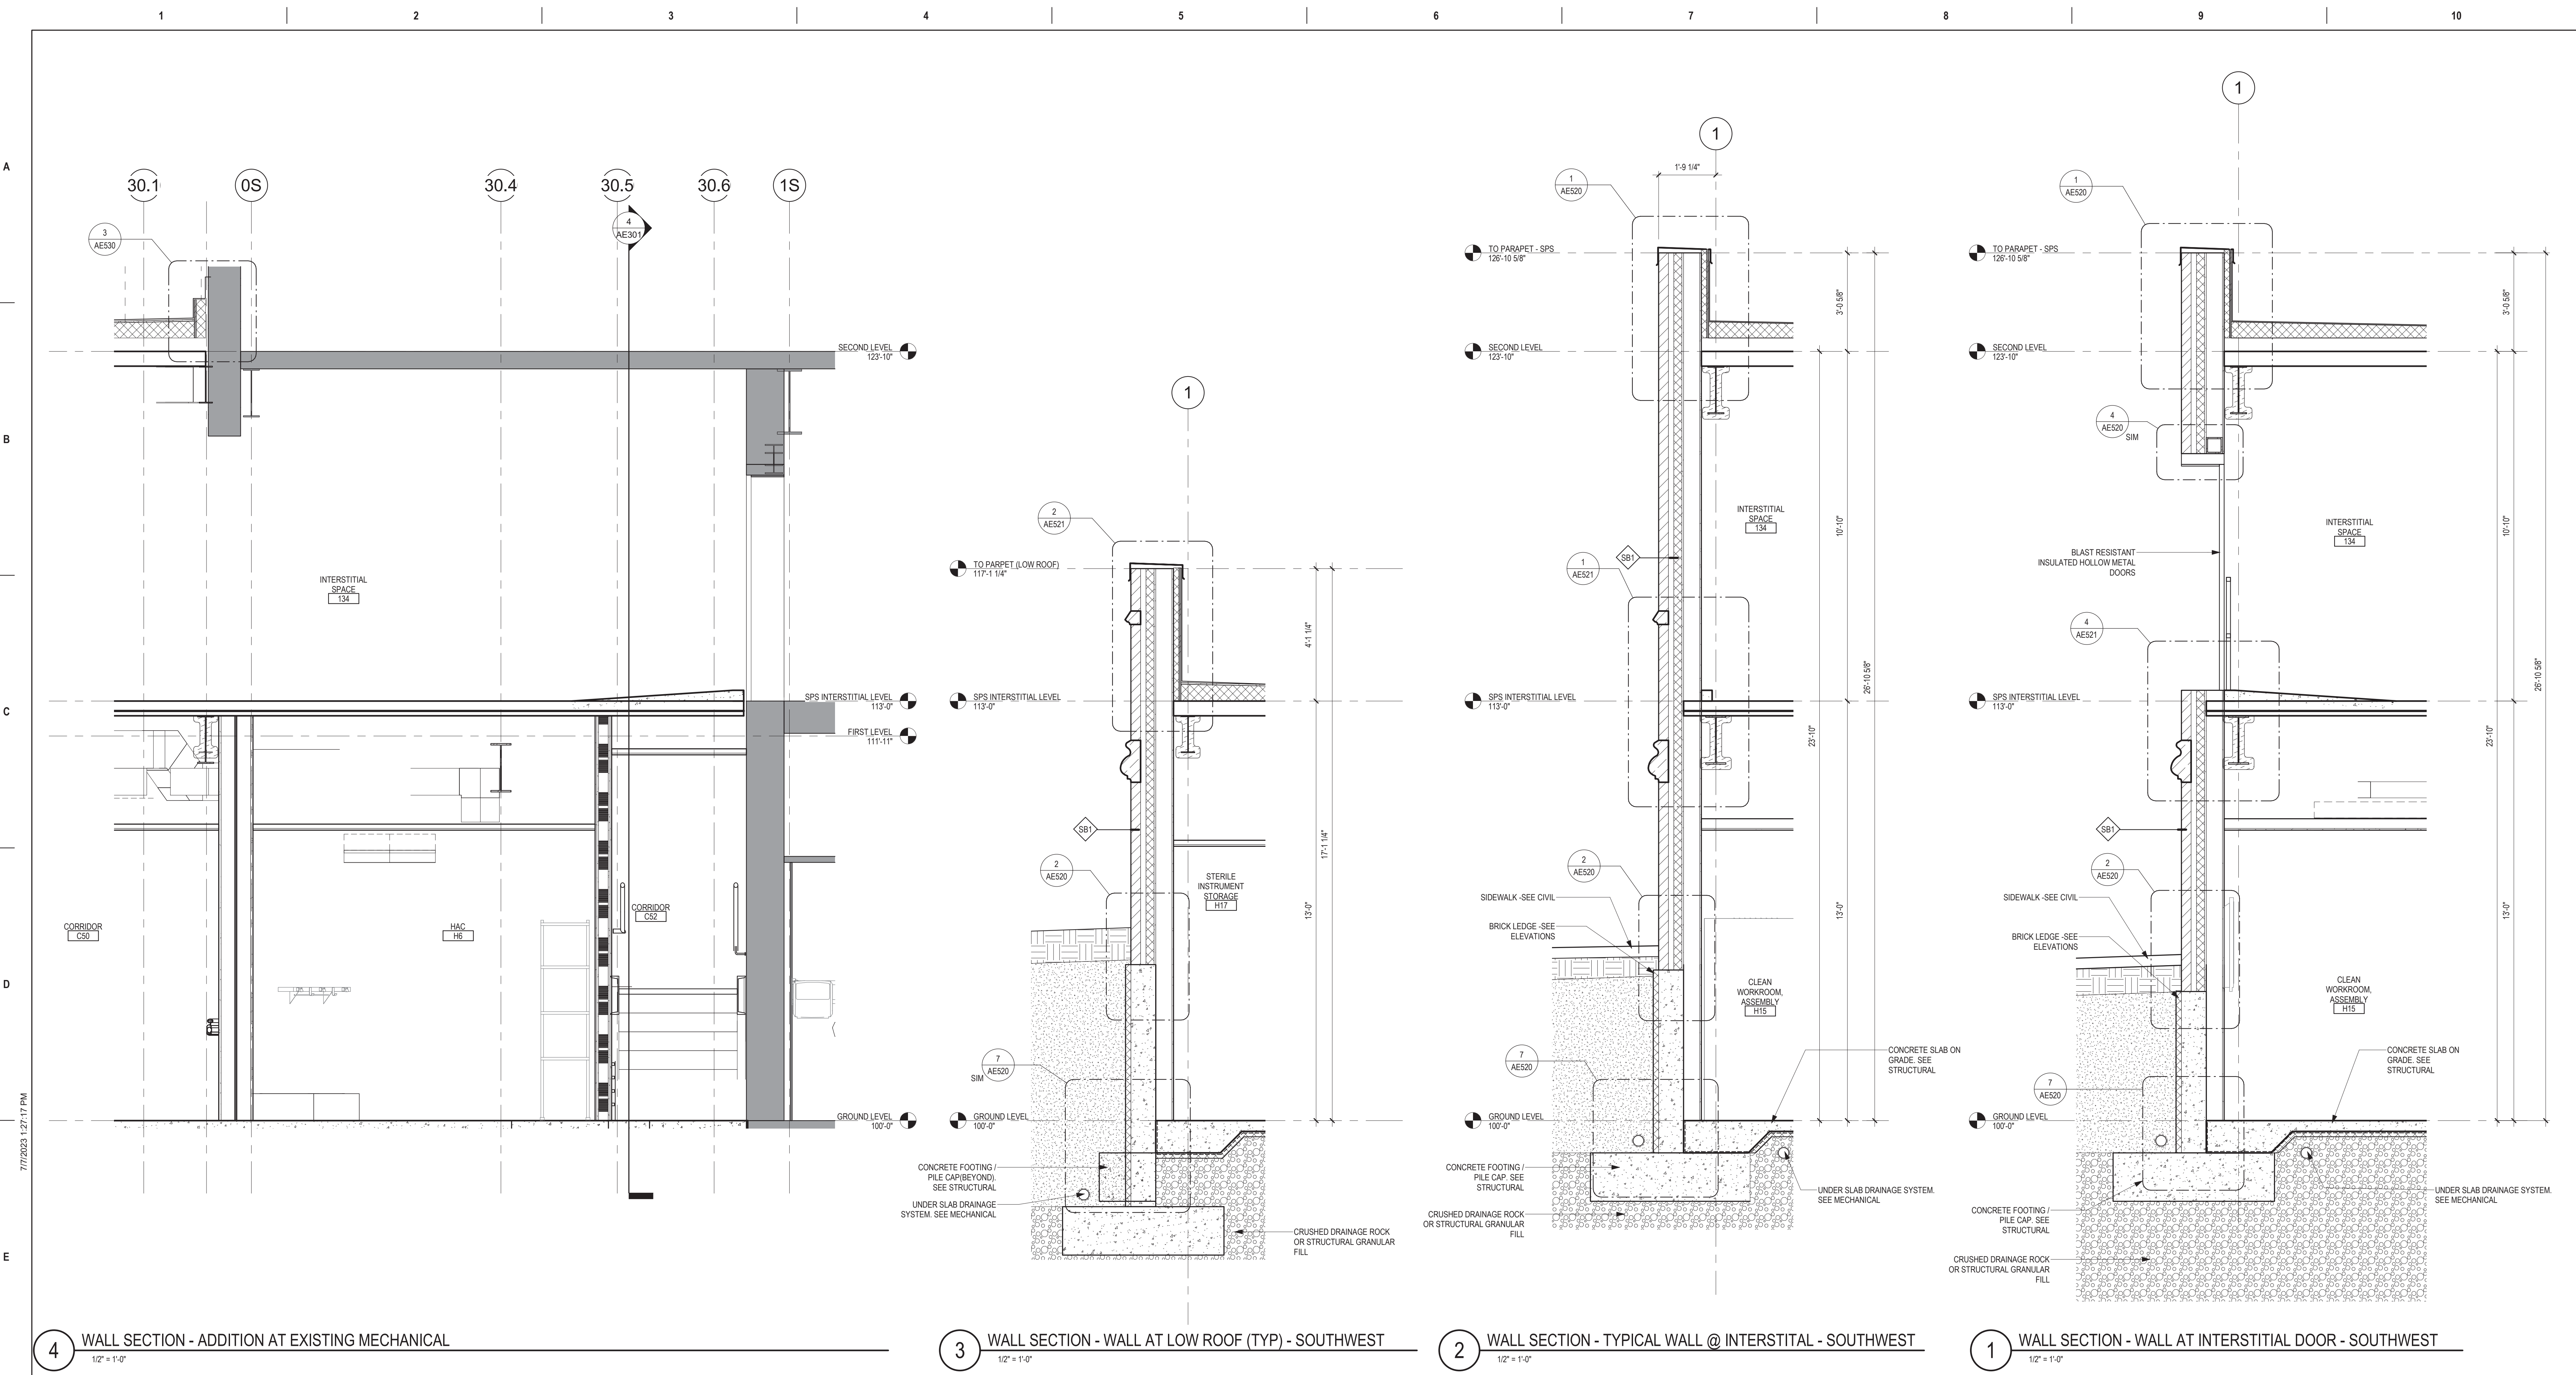


4 WALL SECTION - ADDITION AT EXISTING MECHANICAL
1/2" = 1'-0"

3 WALL SECTION - WALL AT LOW ROOF (TYP) - SOUTHWEST
1/2" = 1'-0"

2 WALL SECTION - TYPICAL WALL @ INTERSTITIAL - SOUTHWEST
1/2" = 1'-0"

1 WALL SECTION - WALL AT INTERSTITIAL DOOR - SOUTHWEST
1/2" = 1'-0"

Revisions: <table border="1"><tr><td> </td><td> </td></tr><tr><td> </td><td> </td></tr><tr><td> </td><td> </td></tr><tr><td> </td><td> </td></tr></table>									CONSULTANT	ARCHITECT/ENGINEER OF RECORD 13605 1st Ave. N. #100 Plymouth, MN 55441 P 763.412.4000 F 763.412.4090 ae-mn.com Anderson Engineering of Minnesota, LLC Proj # 16684	STAMP DATE: 08/04/2022 License # 9335	Office of Construction and Facilities Management U.S. Department of Veterans Affairs	Drawing Title WALL SECTIONS Approved:	Phase BID DOCUMENTS FULLY SPRINKLERED	Project Title CONSTRUCT NEW SPS Location Sioux Falls, SD. Issue Date 08/04/2022 Checked Checker Drawn Author	Project Number 438-460 Building Number 5 Drawing Number AE312

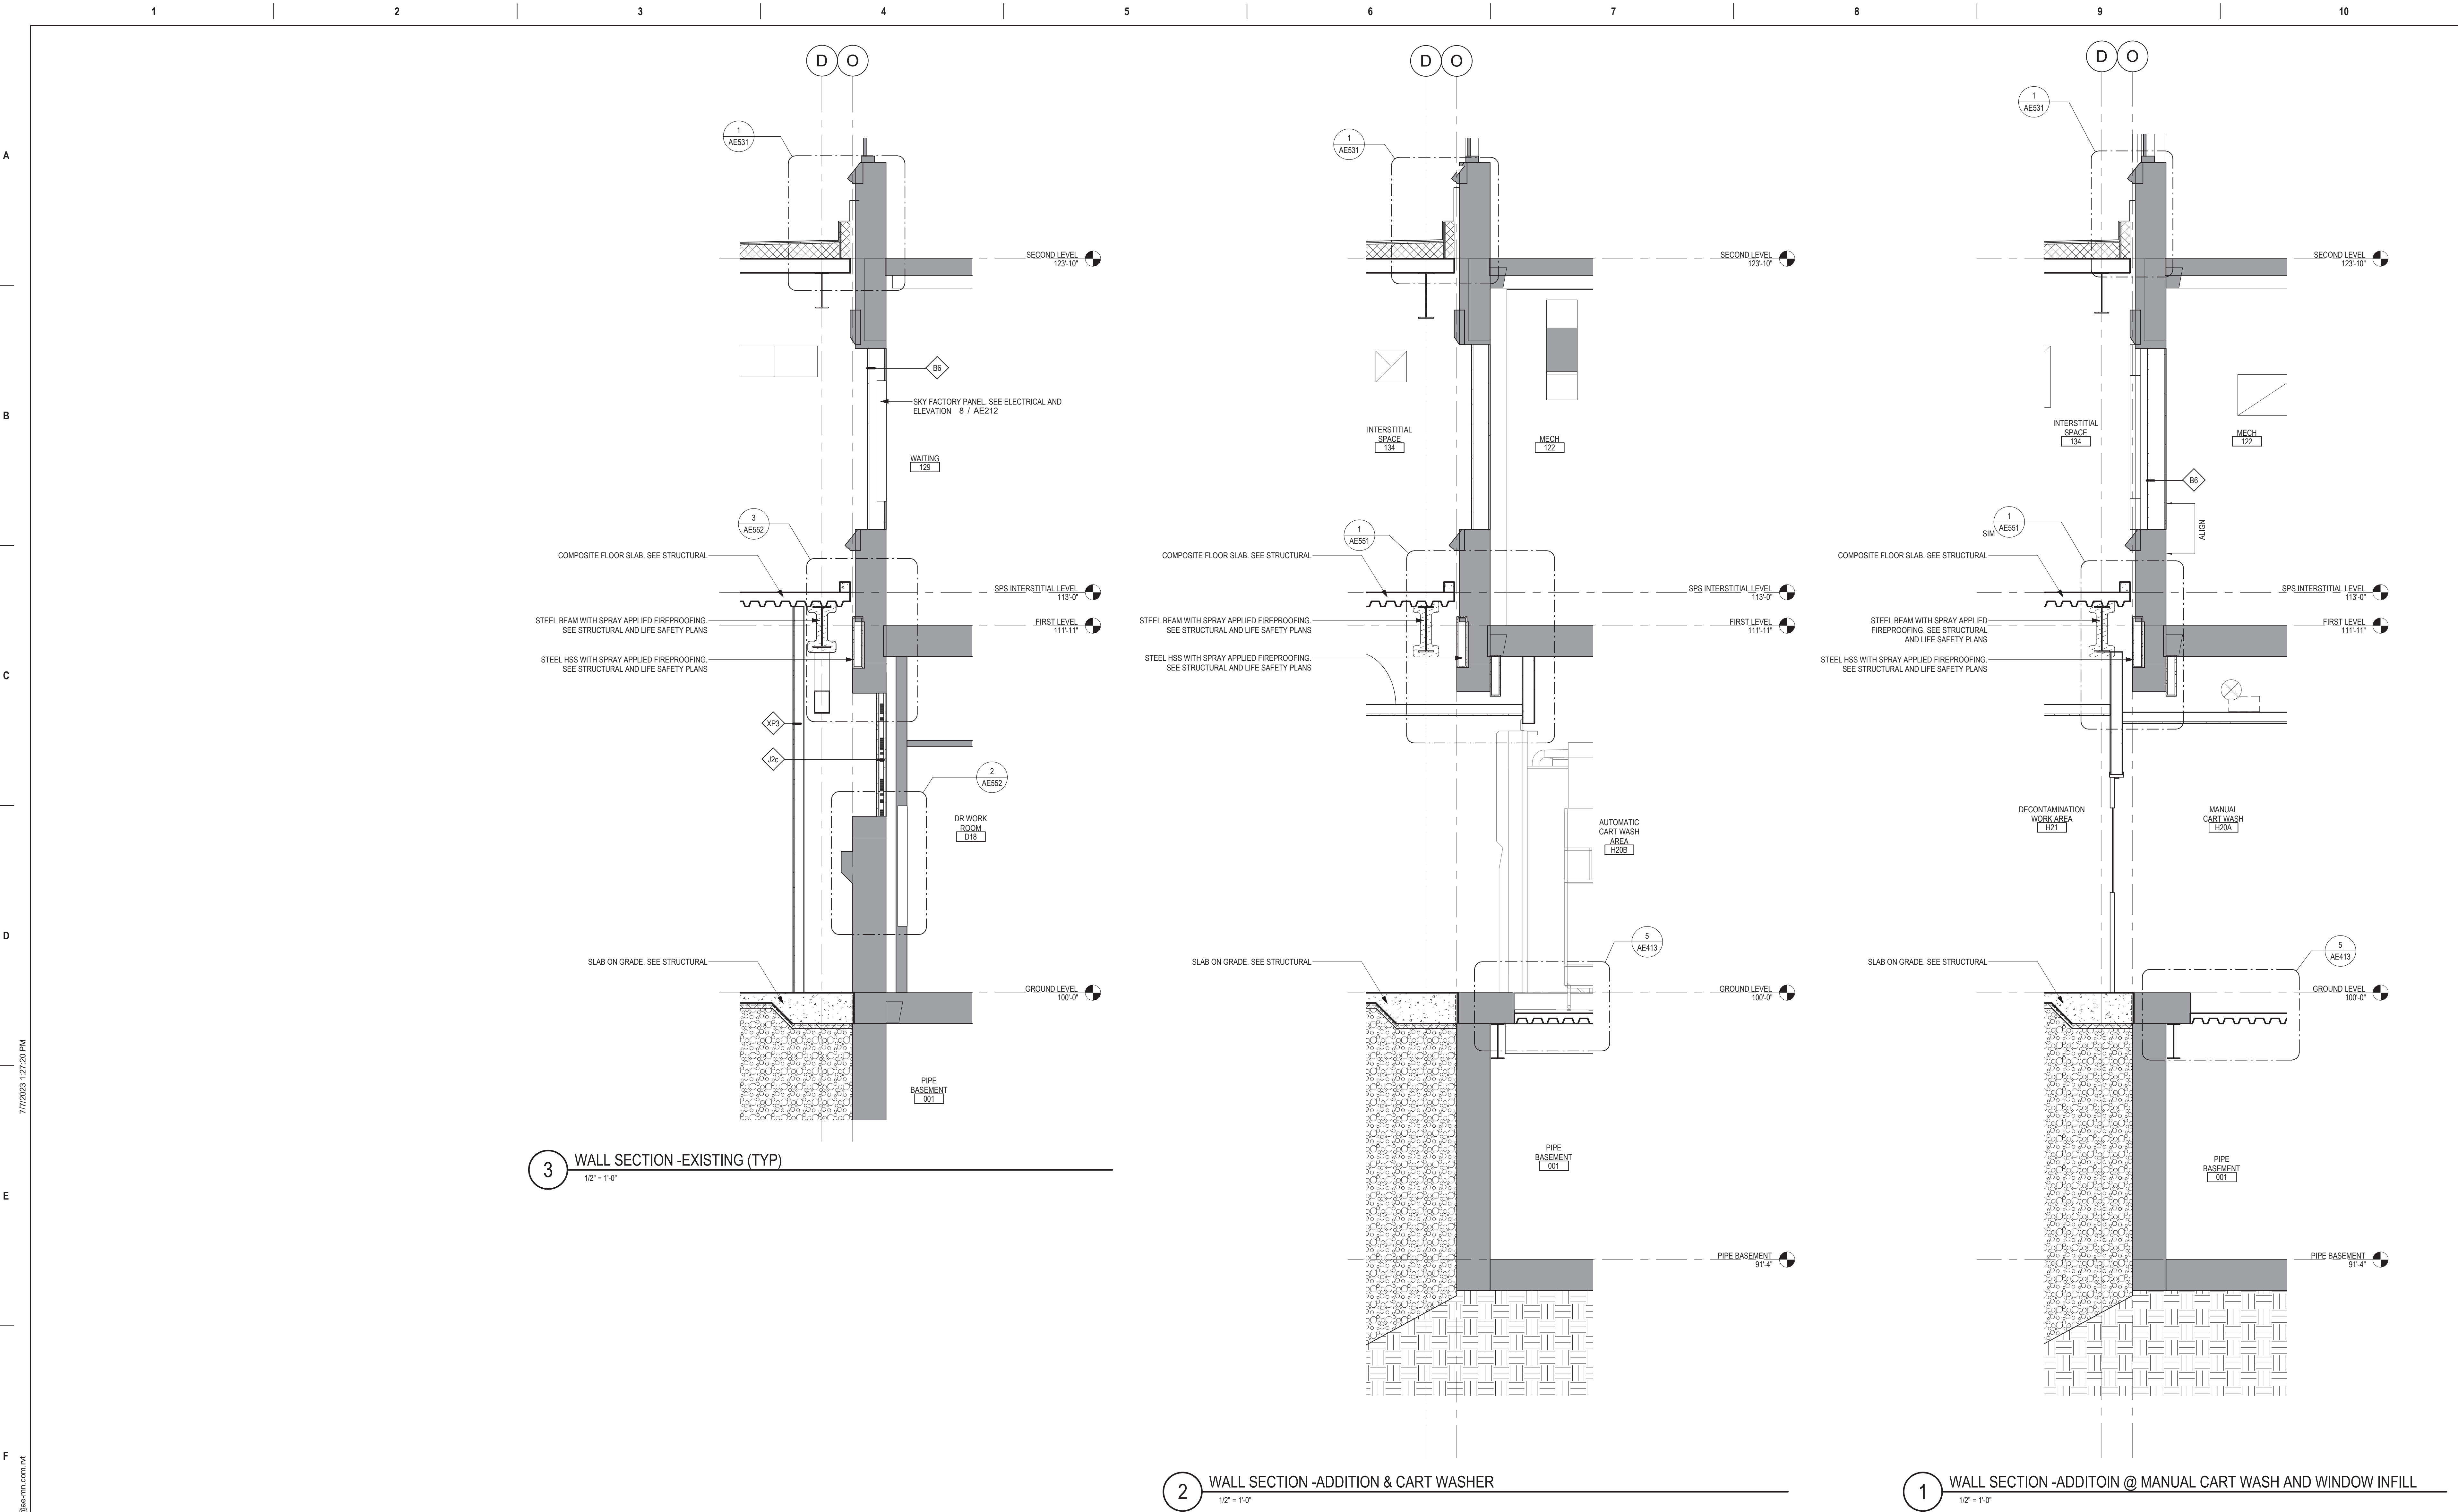

3 WALL SECTION -EXISTING (TYP)
1/2" = 1'-0"

2 WALL SECTION -ADDITION & CART WASHER
1/2" = 1'-0"

1 WALL SECTION -ADDITION @ MANUAL CART WASH AND WINDOW INFILL
1/2" = 1'-0"

Revisions:	Date:

CONSULTANT

IMEG

ARCHITECT/ENGINEER OF RECORD

ANDERSON

13605 1st Ave. N. #100 Plymouth, MN 55441
P 763.412.4000 | F 763.412.4090 | ae-mn.com
Anderson Engineering of Minnesota, LLC | Proj # 16584

STAMP

DATE: 08/04/2022
License # 9335

Office of Construction and Facilities Management

VA U.S. Department of Veterans Affairs

Drawing Title
WALL SECTIONS

Approved:

Phase

BID DOCUMENTS

FULLY SPRINKLERED

Project Title
CONSTRUCT NEW SPS

Location
Sioux Falls, SD.

Issue Date
08/04/2022

Checked
Checker


Drawn
Author

Project Number
438-460


Building Number
5


Drawing Number
AE313

C:\Users\Public\Documents\Revit Projects\16584-RCT1_gbarani@ae-mn.com.rvt 7/7/2023 1:27:20 PM

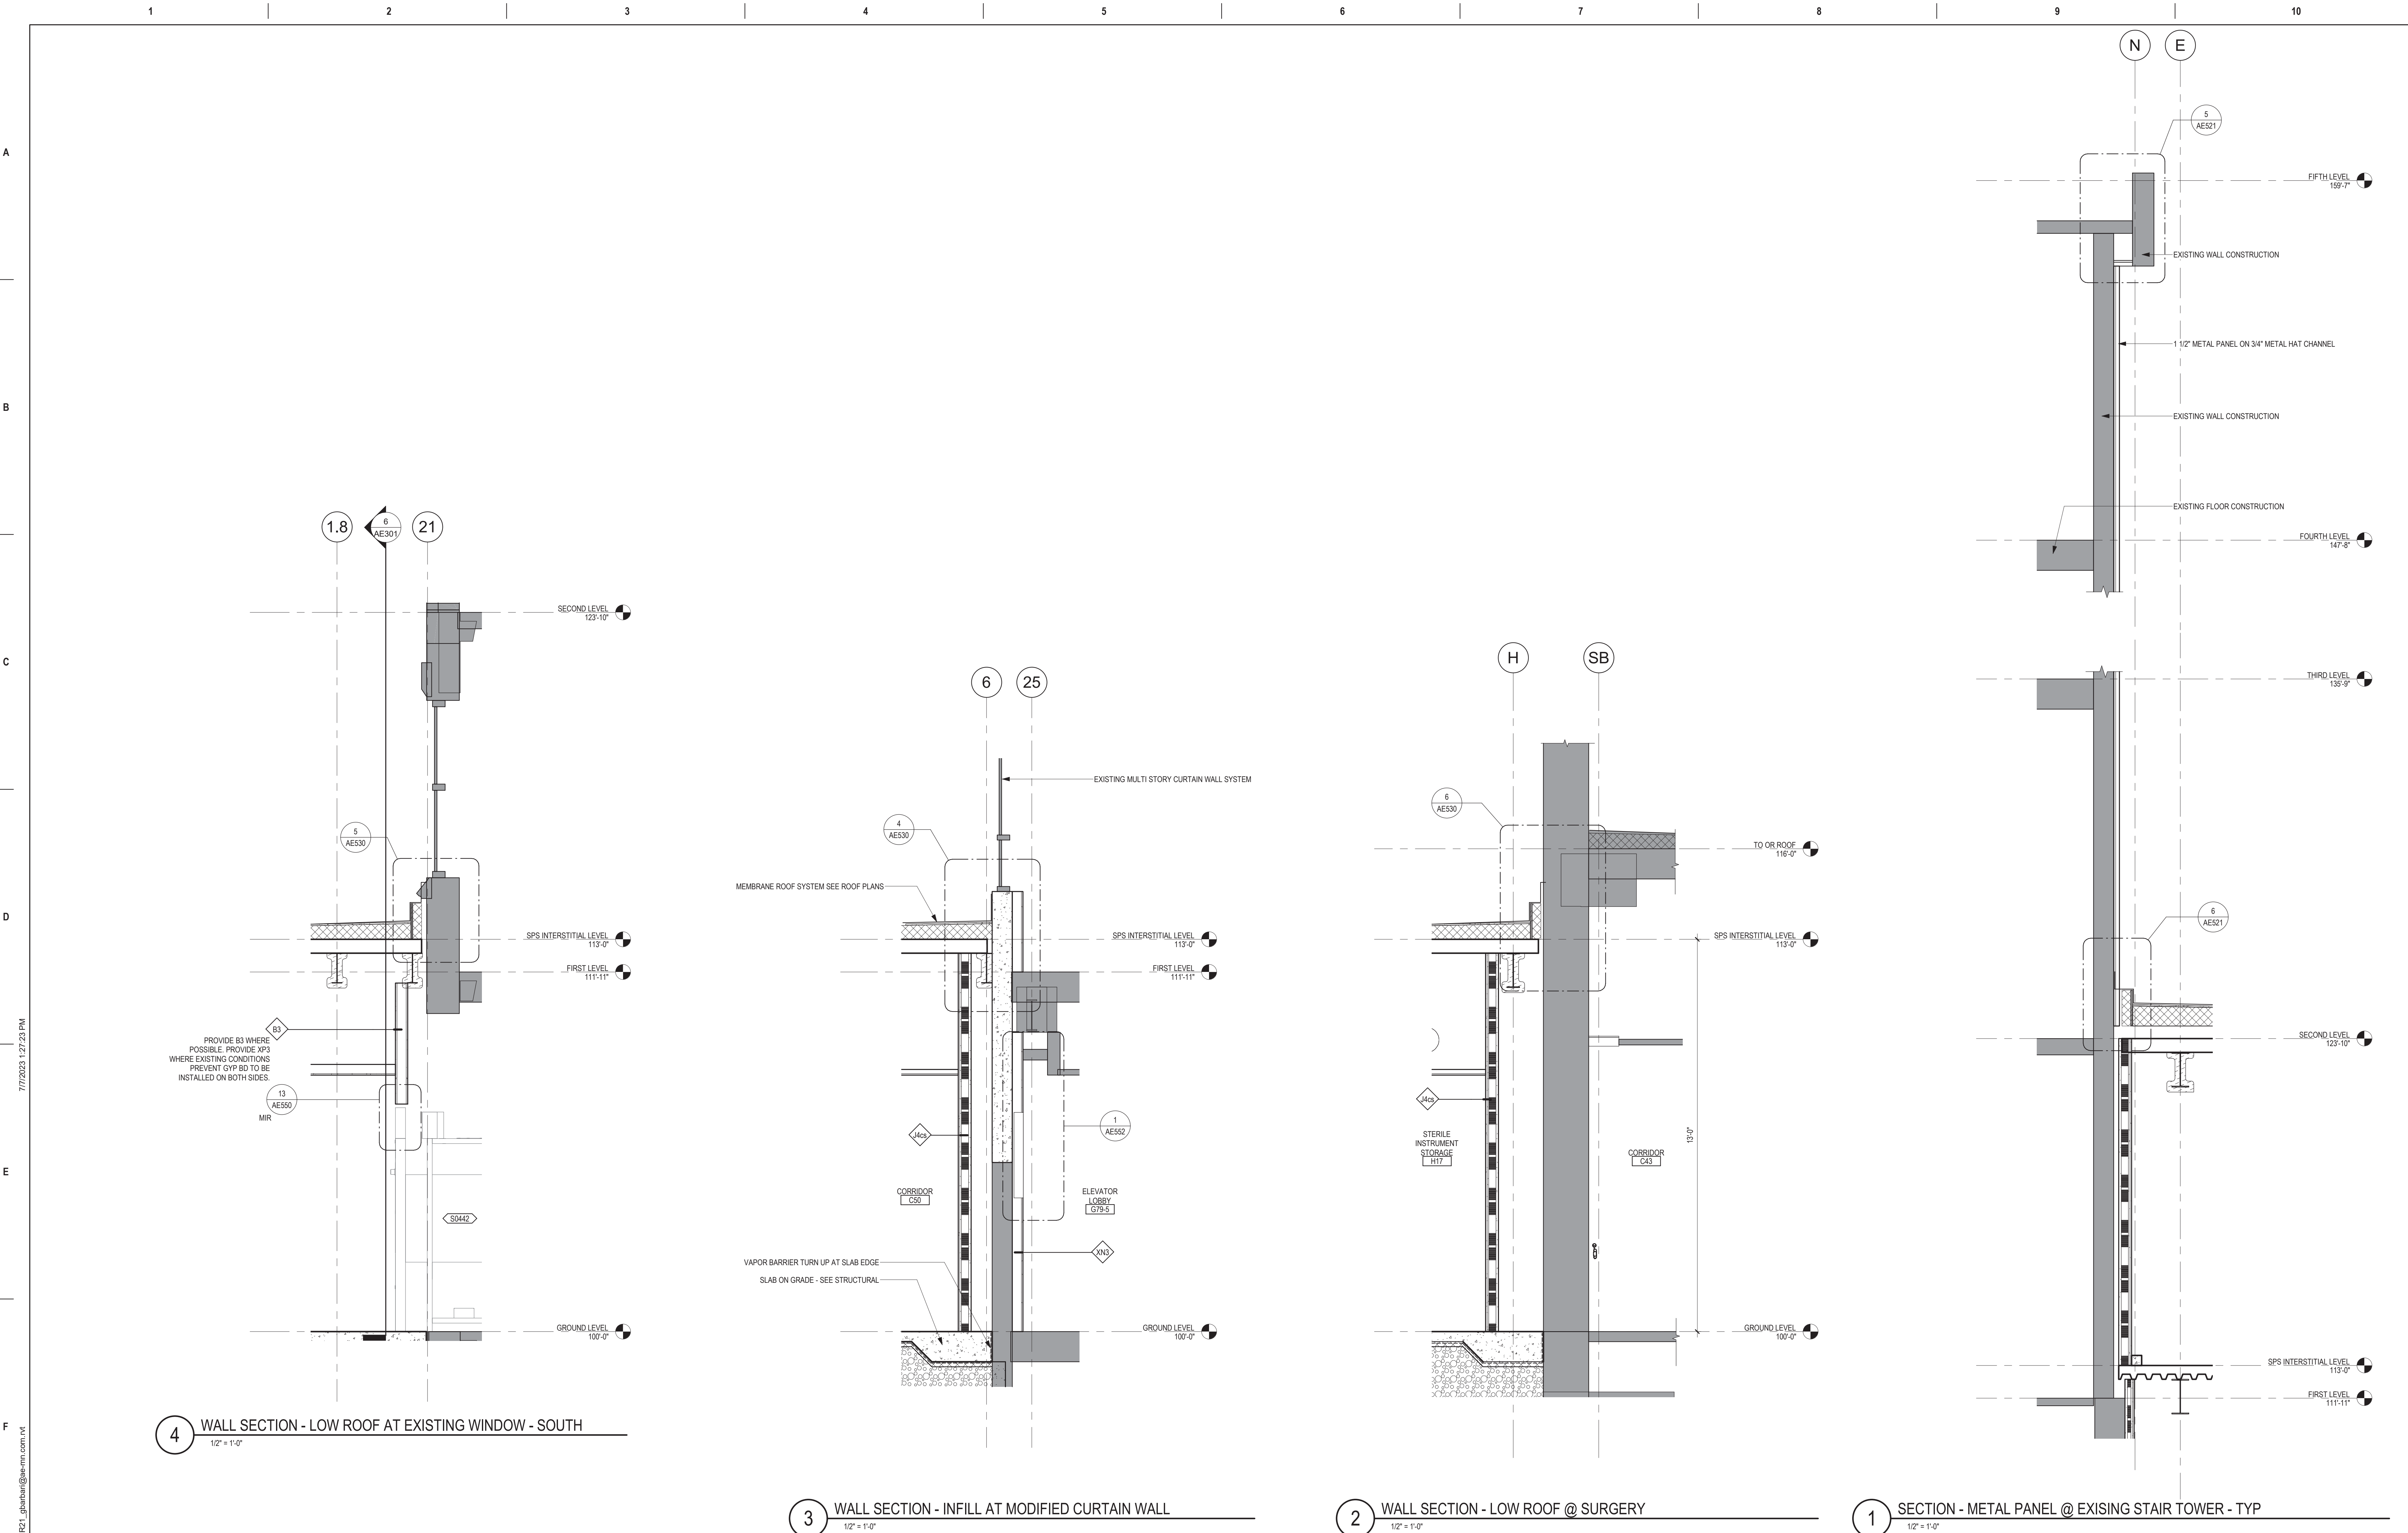


 C:\Users\Public\Documents\Revit Projects\16584-R21_gbarani@ae-mn.com.rvt 7/7/2023 1:27:23 PM

		CONSULTANT 		ARCHITECT/ENGINEER OF RECORD  13605 1st Ave. N. #100 Plymouth, MN 55441 P 763.412.4000 F 763.412.4090 ae-mn.com Anderson Engineering of Minnesota, LLC Proj # 16584		STAMP 		Office of Construction and Facilities Management  U.S. Department of Veterans Affairs		Drawing Title WALL SECTIONS Approved:		Phase BID DOCUMENTS FULLY SPRINKLERED		Project Title CONSTRUCT NEW SPS Location Sioux Falls, SD. Issue Date 08/04/2022 Checked Checker Drawn Author		Project Number 438-460 Building Number 5 Drawing Number AE314	
--	--	--	--	---	--	---	--	--	--	--	--	--	--	--	--	--	--

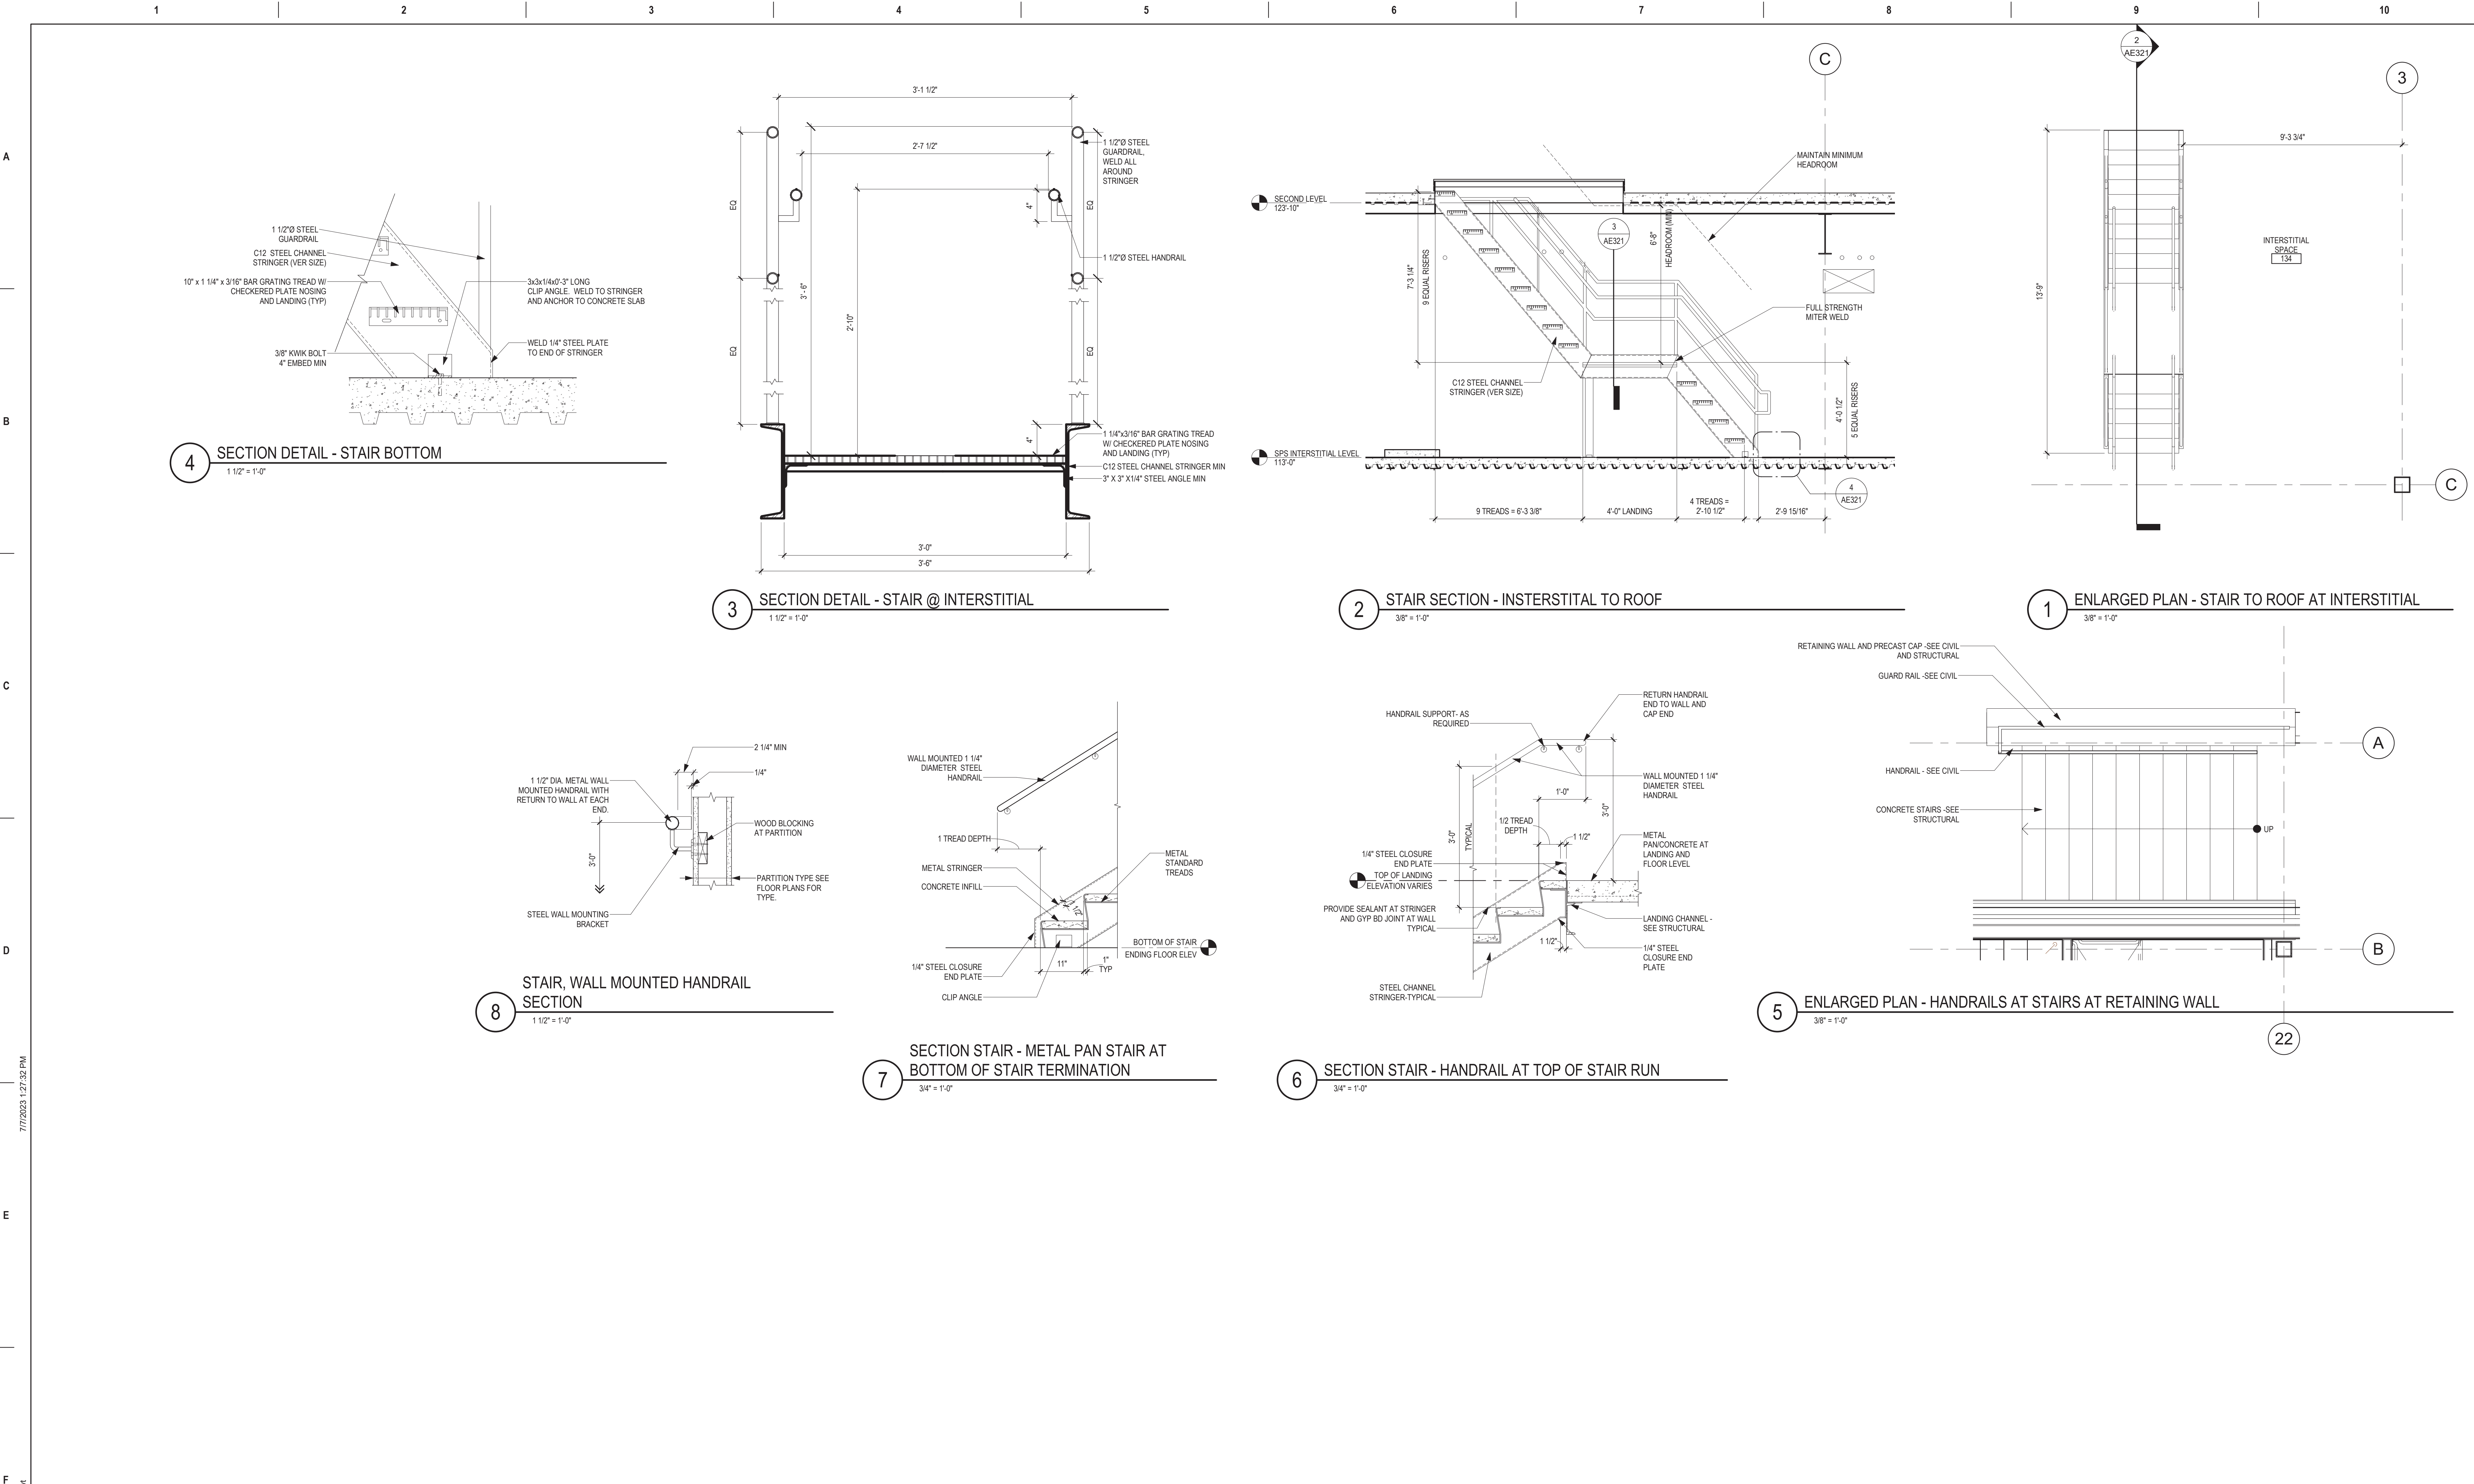

Revisions: Date:		CONSULTANT IMEG		ARCHITECT/ENGINEER OF RECORD ANDERSON 13605 1st Ave. N. #100 Plymouth, MN 55441 P 763.412.4000 F 763.412.4090 ae-mn.com Anderson Engineering of Minnesota, LLC Proj # 16684		STAMP Professional Engineer Seal for Thomas A. Olesak, State of Minnesota, License # 9335, dated 08/04/2022.	Office of Construction and Facilities Management VA U.S. Department of Veterans Affairs	Drawing Title STAIR SECTIONS AND ENLARGED PLANS Approved:	Phase BID DOCUMENTS FULLY SPRINKLERED	Project Title CONSTRUCT NEW SPS Location Sioux Falls, SD. Issue Date 08/04/2022 Checked Checker Drawn Author	Project Number 438-460 Building Number 5 Drawing Number AE321
--	--	---------------------------------------	--	--	--	--	---	--	--	--	---

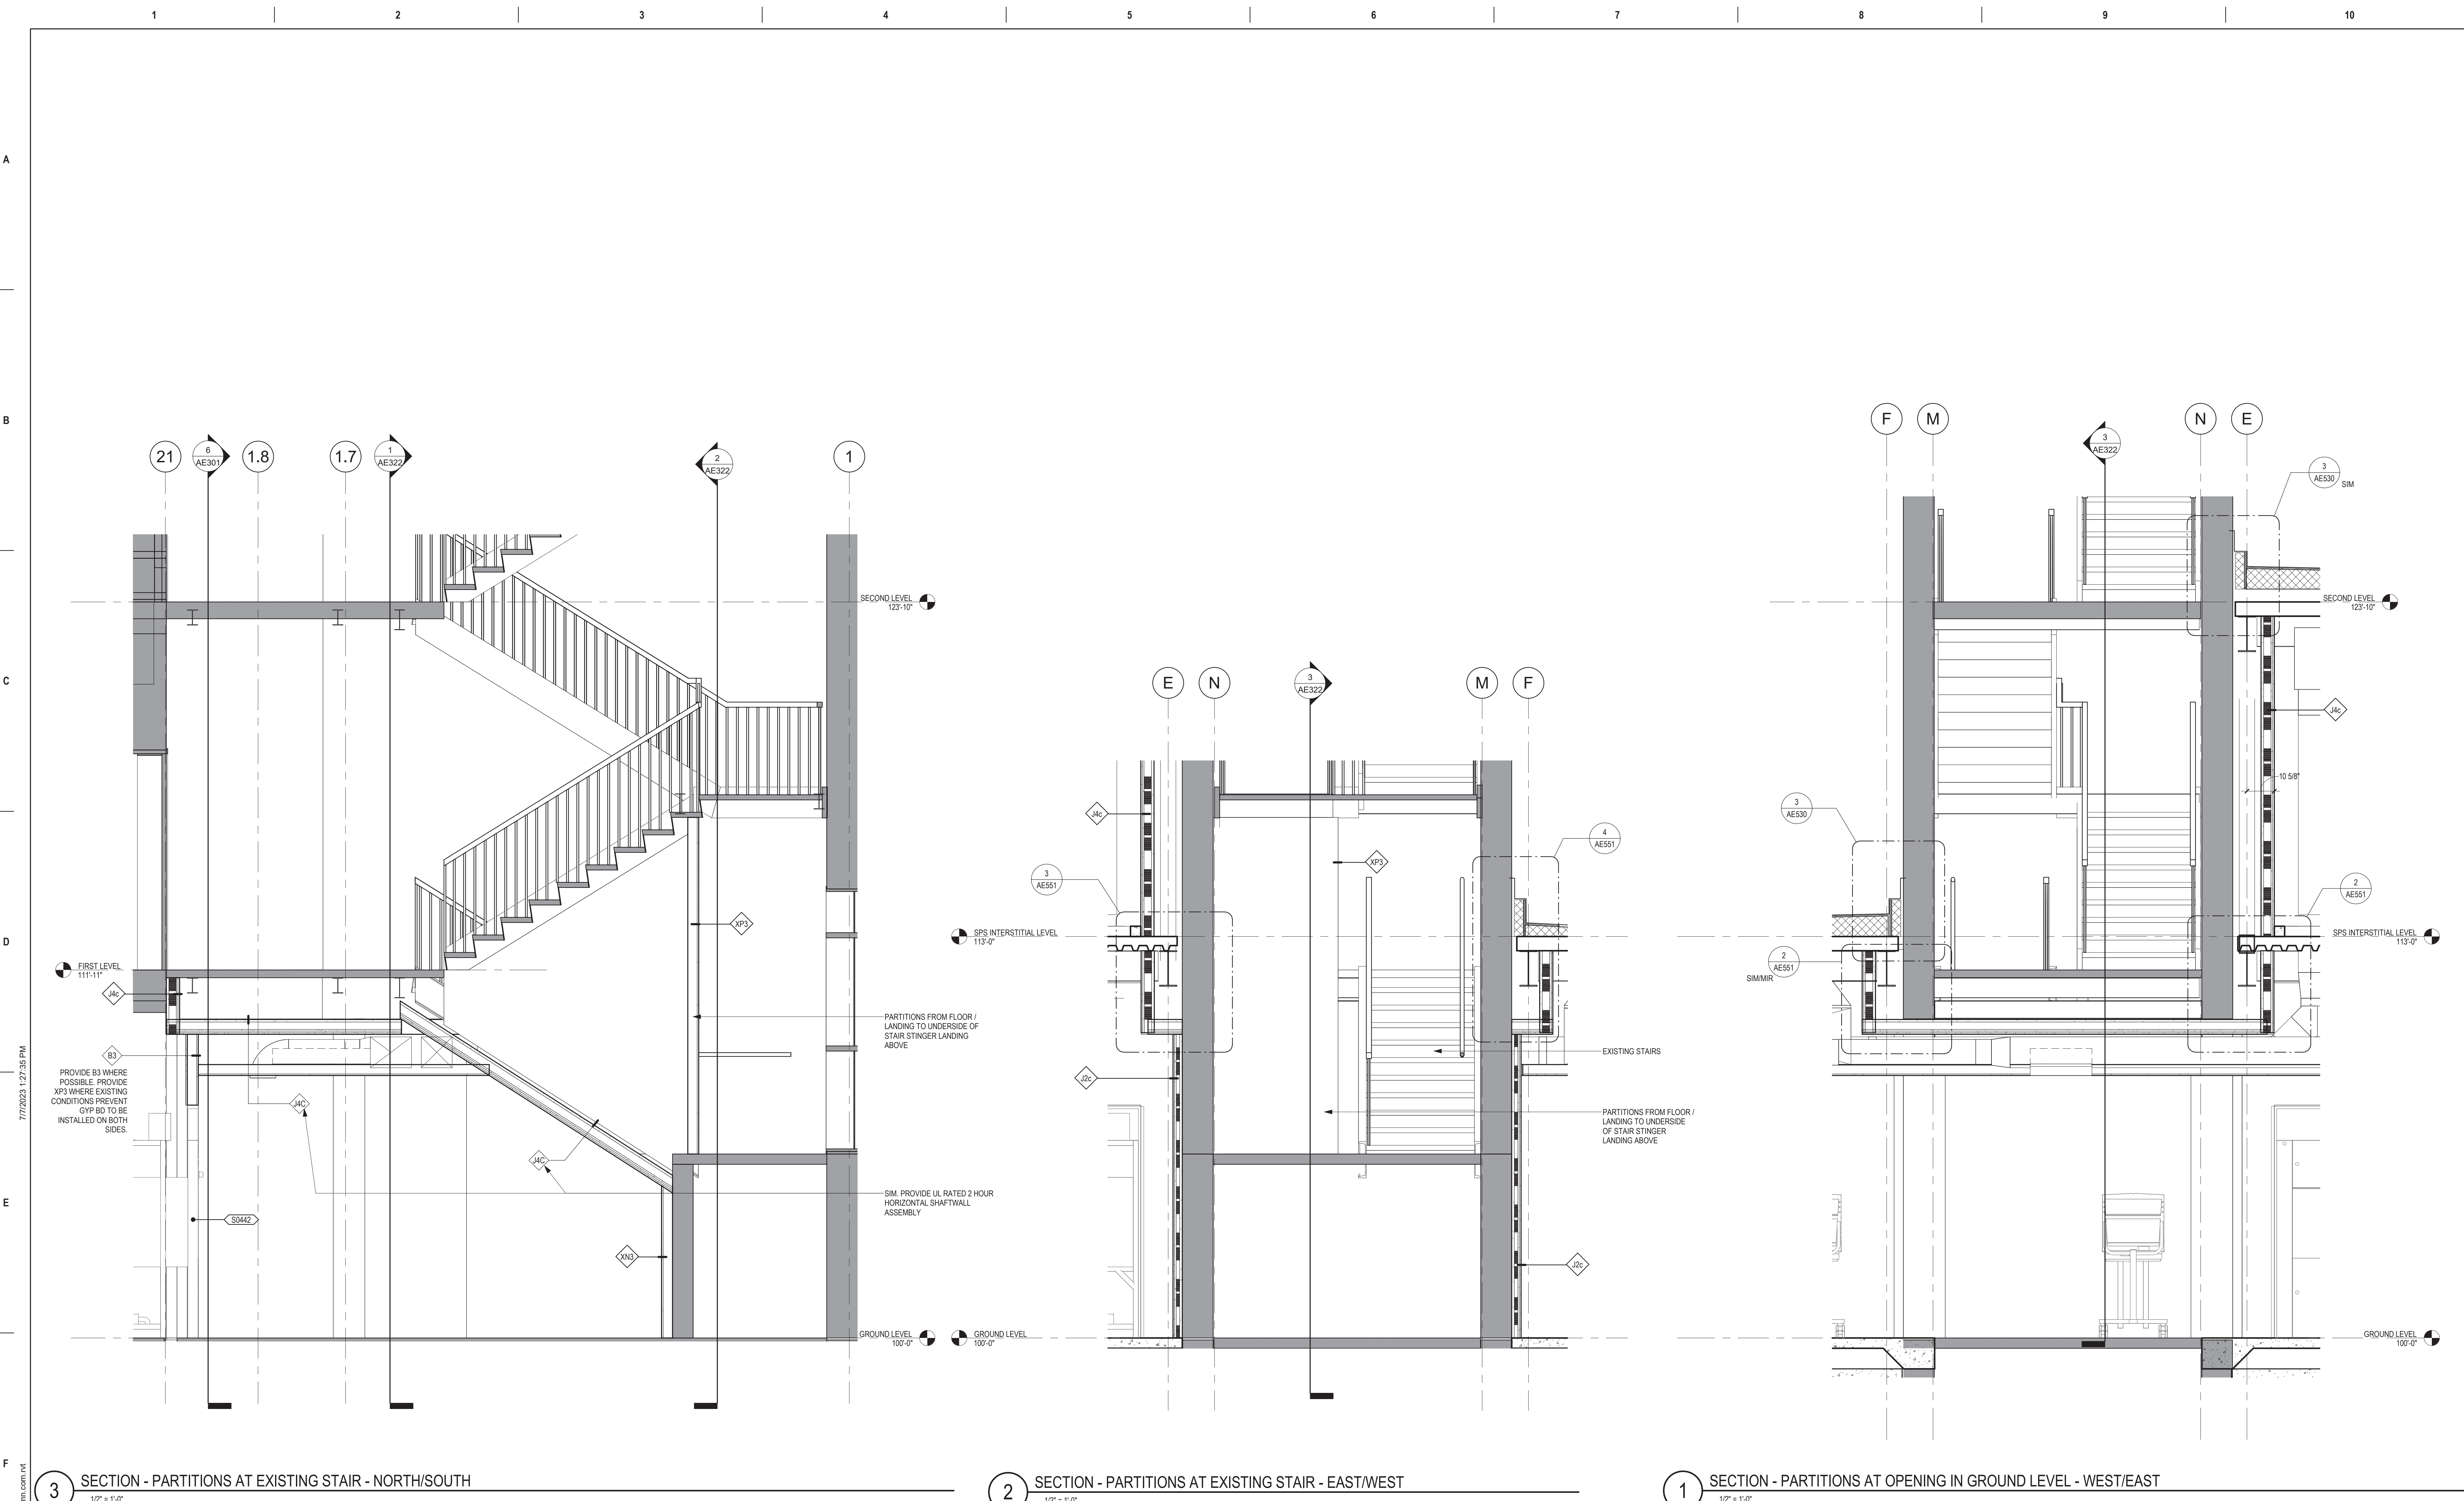

3 SECTION - PARTITIONS AT EXISTING STAIR - NORTH/SOUTH
1/2" = 1'-0"

2 SECTION - PARTITIONS AT EXISTING STAIR - EAST/WEST
1/2" = 1'-0"

1 SECTION - PARTITIONS AT OPENING IN GROUND LEVEL - WEST/EAST
1/2" = 1'-0"

Revisions:	Date:

CONSULTANT

IMEG

ARCHITECT/ENGINEER OF RECORD

ANDERSON

13605 1st Ave. N. #100 Plymouth, MN 55441
P 763.412.4000 | F 763.412.4090 | ae-mn.com
Anderson Engineering of Minnesota, LLC | Proj # 16684

STAMP

DATE: 08/04/2022
License # 9335

Office of Construction and Facilities Management

VA U.S. Department of Veterans Affairs

Drawing Title
STAIR SECTIONS - PARTITIONS AT EXISTING STAIR

Approved:

Phase
BID DOCUMENTS

FULLY SPRINKLERED

Project Title
CONSTRUCT NEW SPS

Location
Sioux Falls, SD.

Issue Date
08/04/2022


Checked
Checker

Drawn
Author

Project Number
438-460

Building Number
5

Drawing Number
AE322

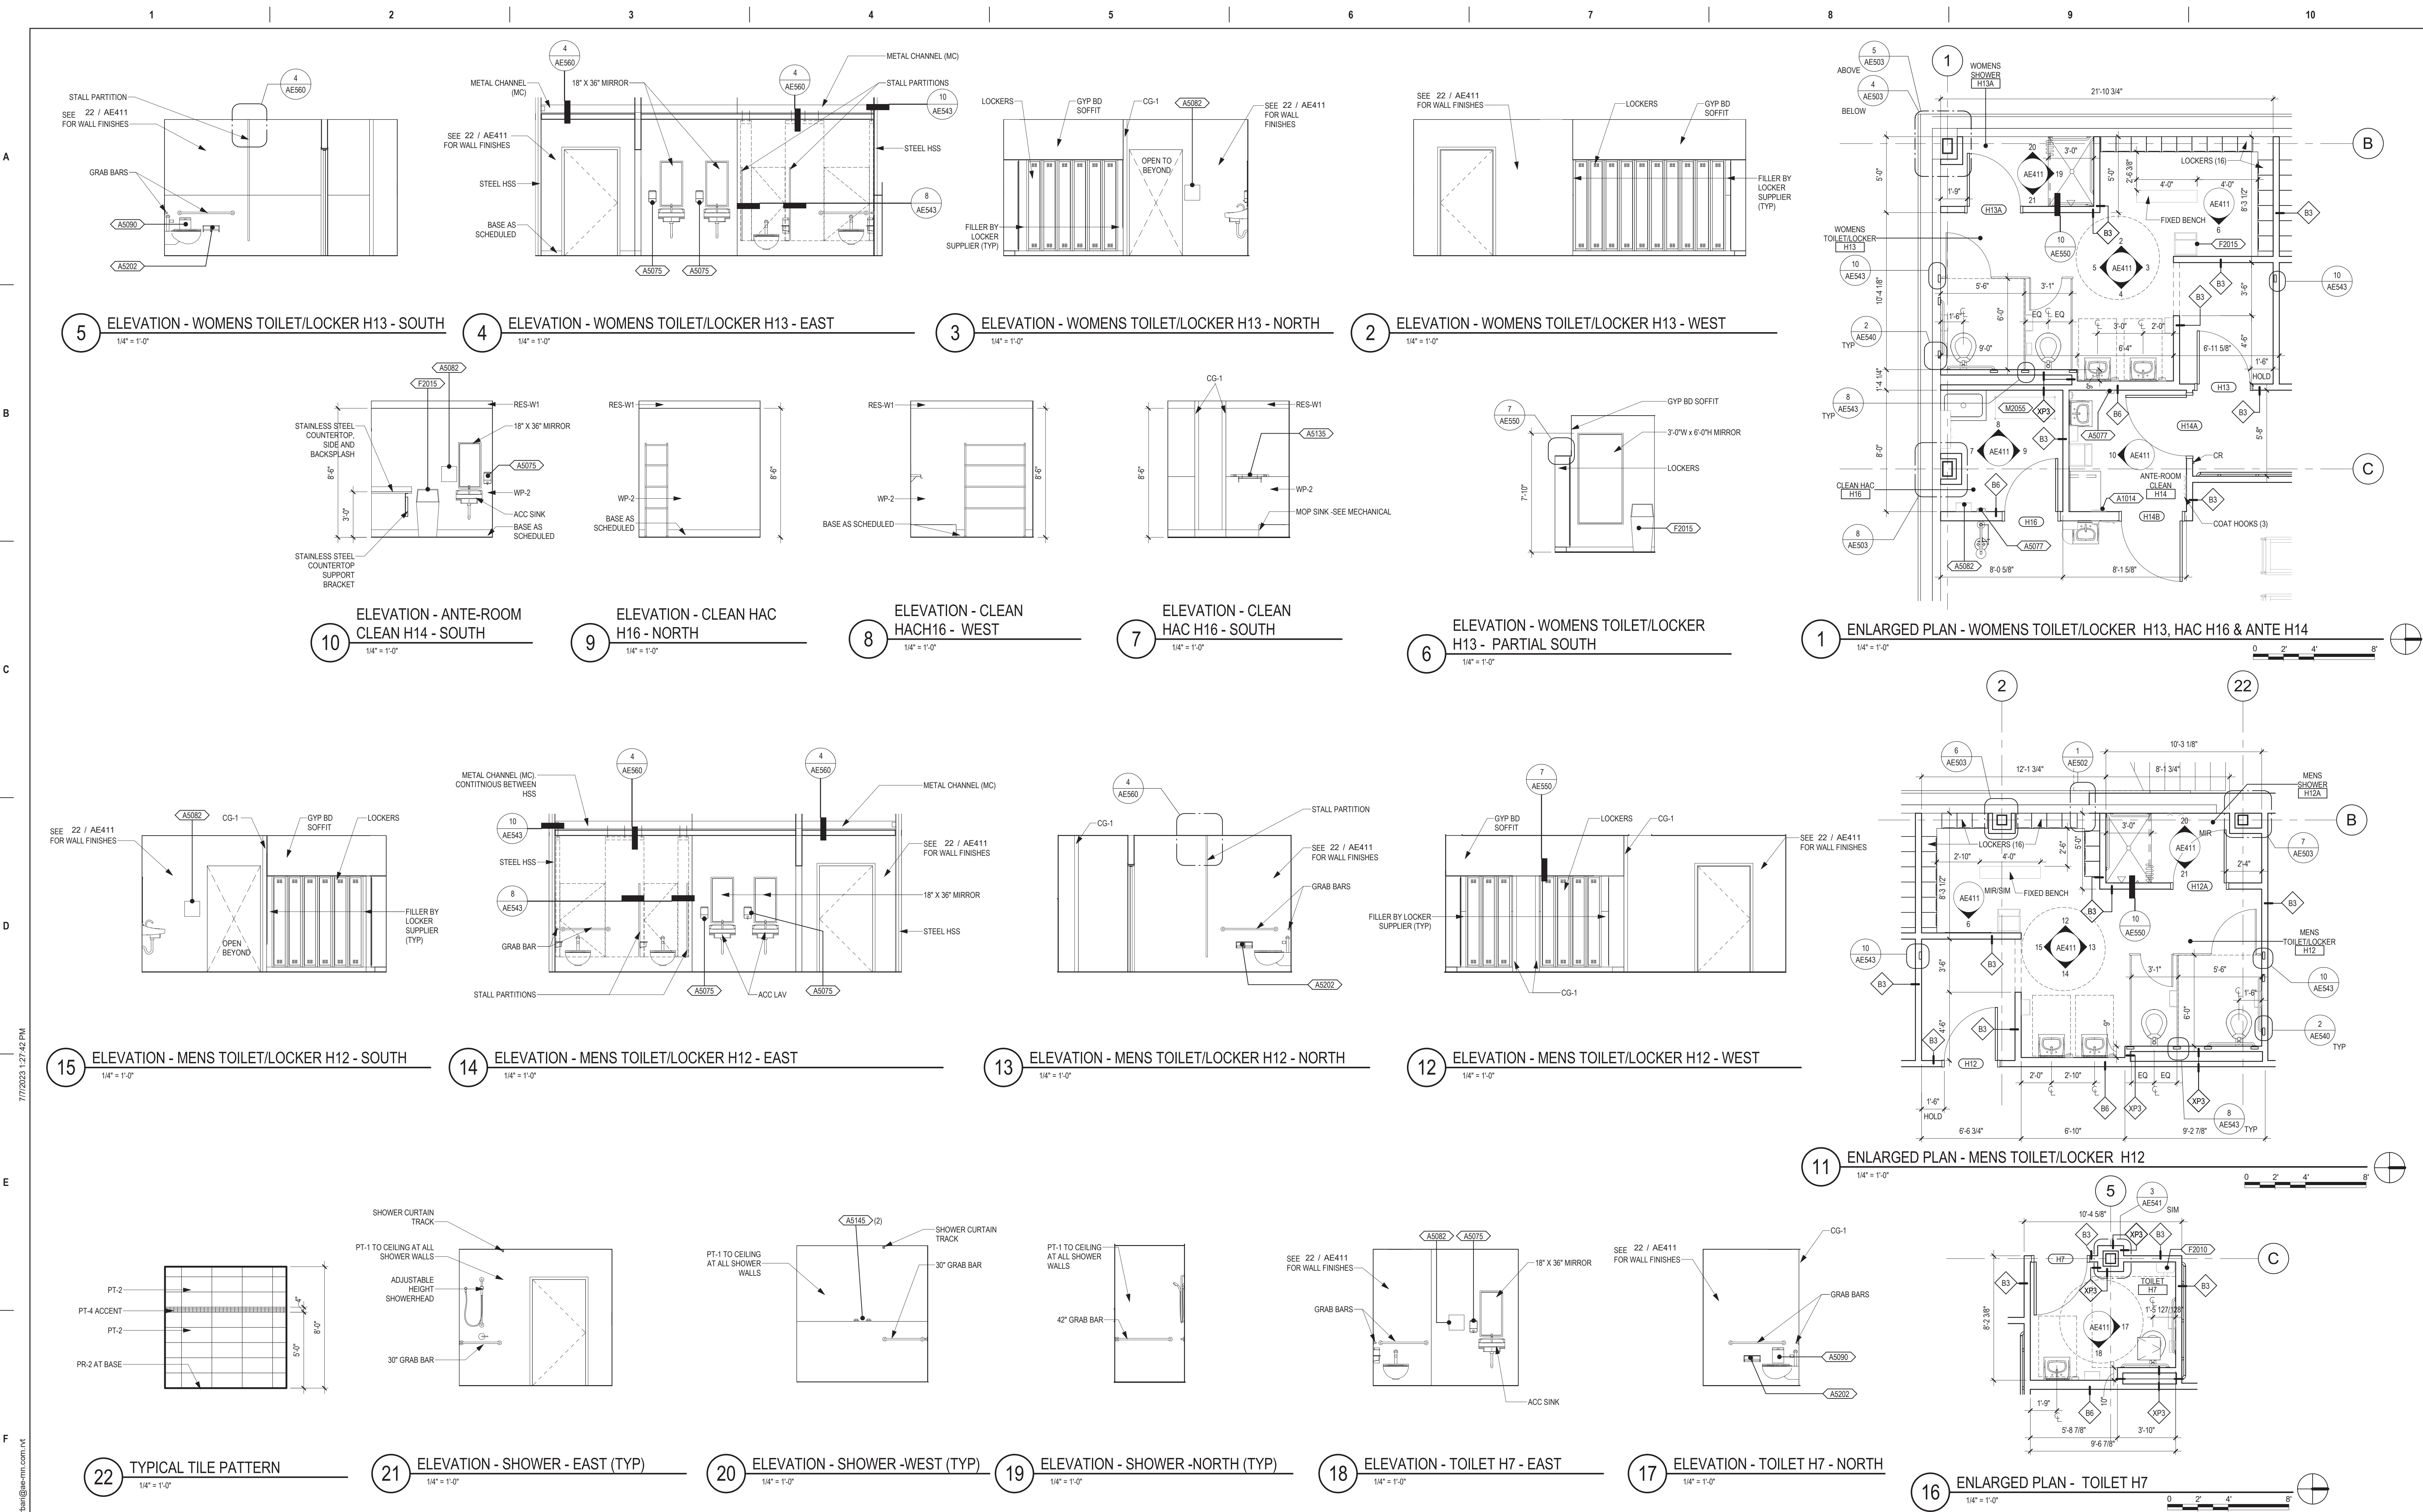

Revisions: Date:		CONSULTANT IMEG	ARCHITECT/ENGINEER OF RECORD ANDERSON 13605 1st Ave. N. #100 Plymouth, MN 55441 P 763.412.4000 F 763.412.4090 a-e-mn.com Anderson Engineering of Minnesota, LLC Proj # 16584	STAMP DATE: 08/04/2022 License # 9335	Office of Construction and Facilities Management VA U.S. Department of Veterans Affairs	Drawing Title ENLARGED PLANS & INTERIOR ELEVATIONS Approved:	Phase BID DOCUMENTS FULLY SPRINKLERED	Project Title CONSTRUCT NEW SPS Location Sioux Falls, SD. Issue Date 08/04/2022 Checked Checker Drawn Author	Project Number 438-460 Building Number 5 Drawing Number AE411
--	--	---------------------------------------	---	---	---	---	--	--	--



Phase	Project Title		Project Number	
BID DOCUMENTS	CONSTRUCT NEW SPS		438-460	
			Building Number	
			5	
	Location		Drawing Number	
	Sioux Falls, SD.		AE413	
FULLY SPRINKLERED	Issue Date	Checked	Drawn	
	08/04/2022	Checker	Author	

A

B

C

D

E

F

A


B

C


D

E


F

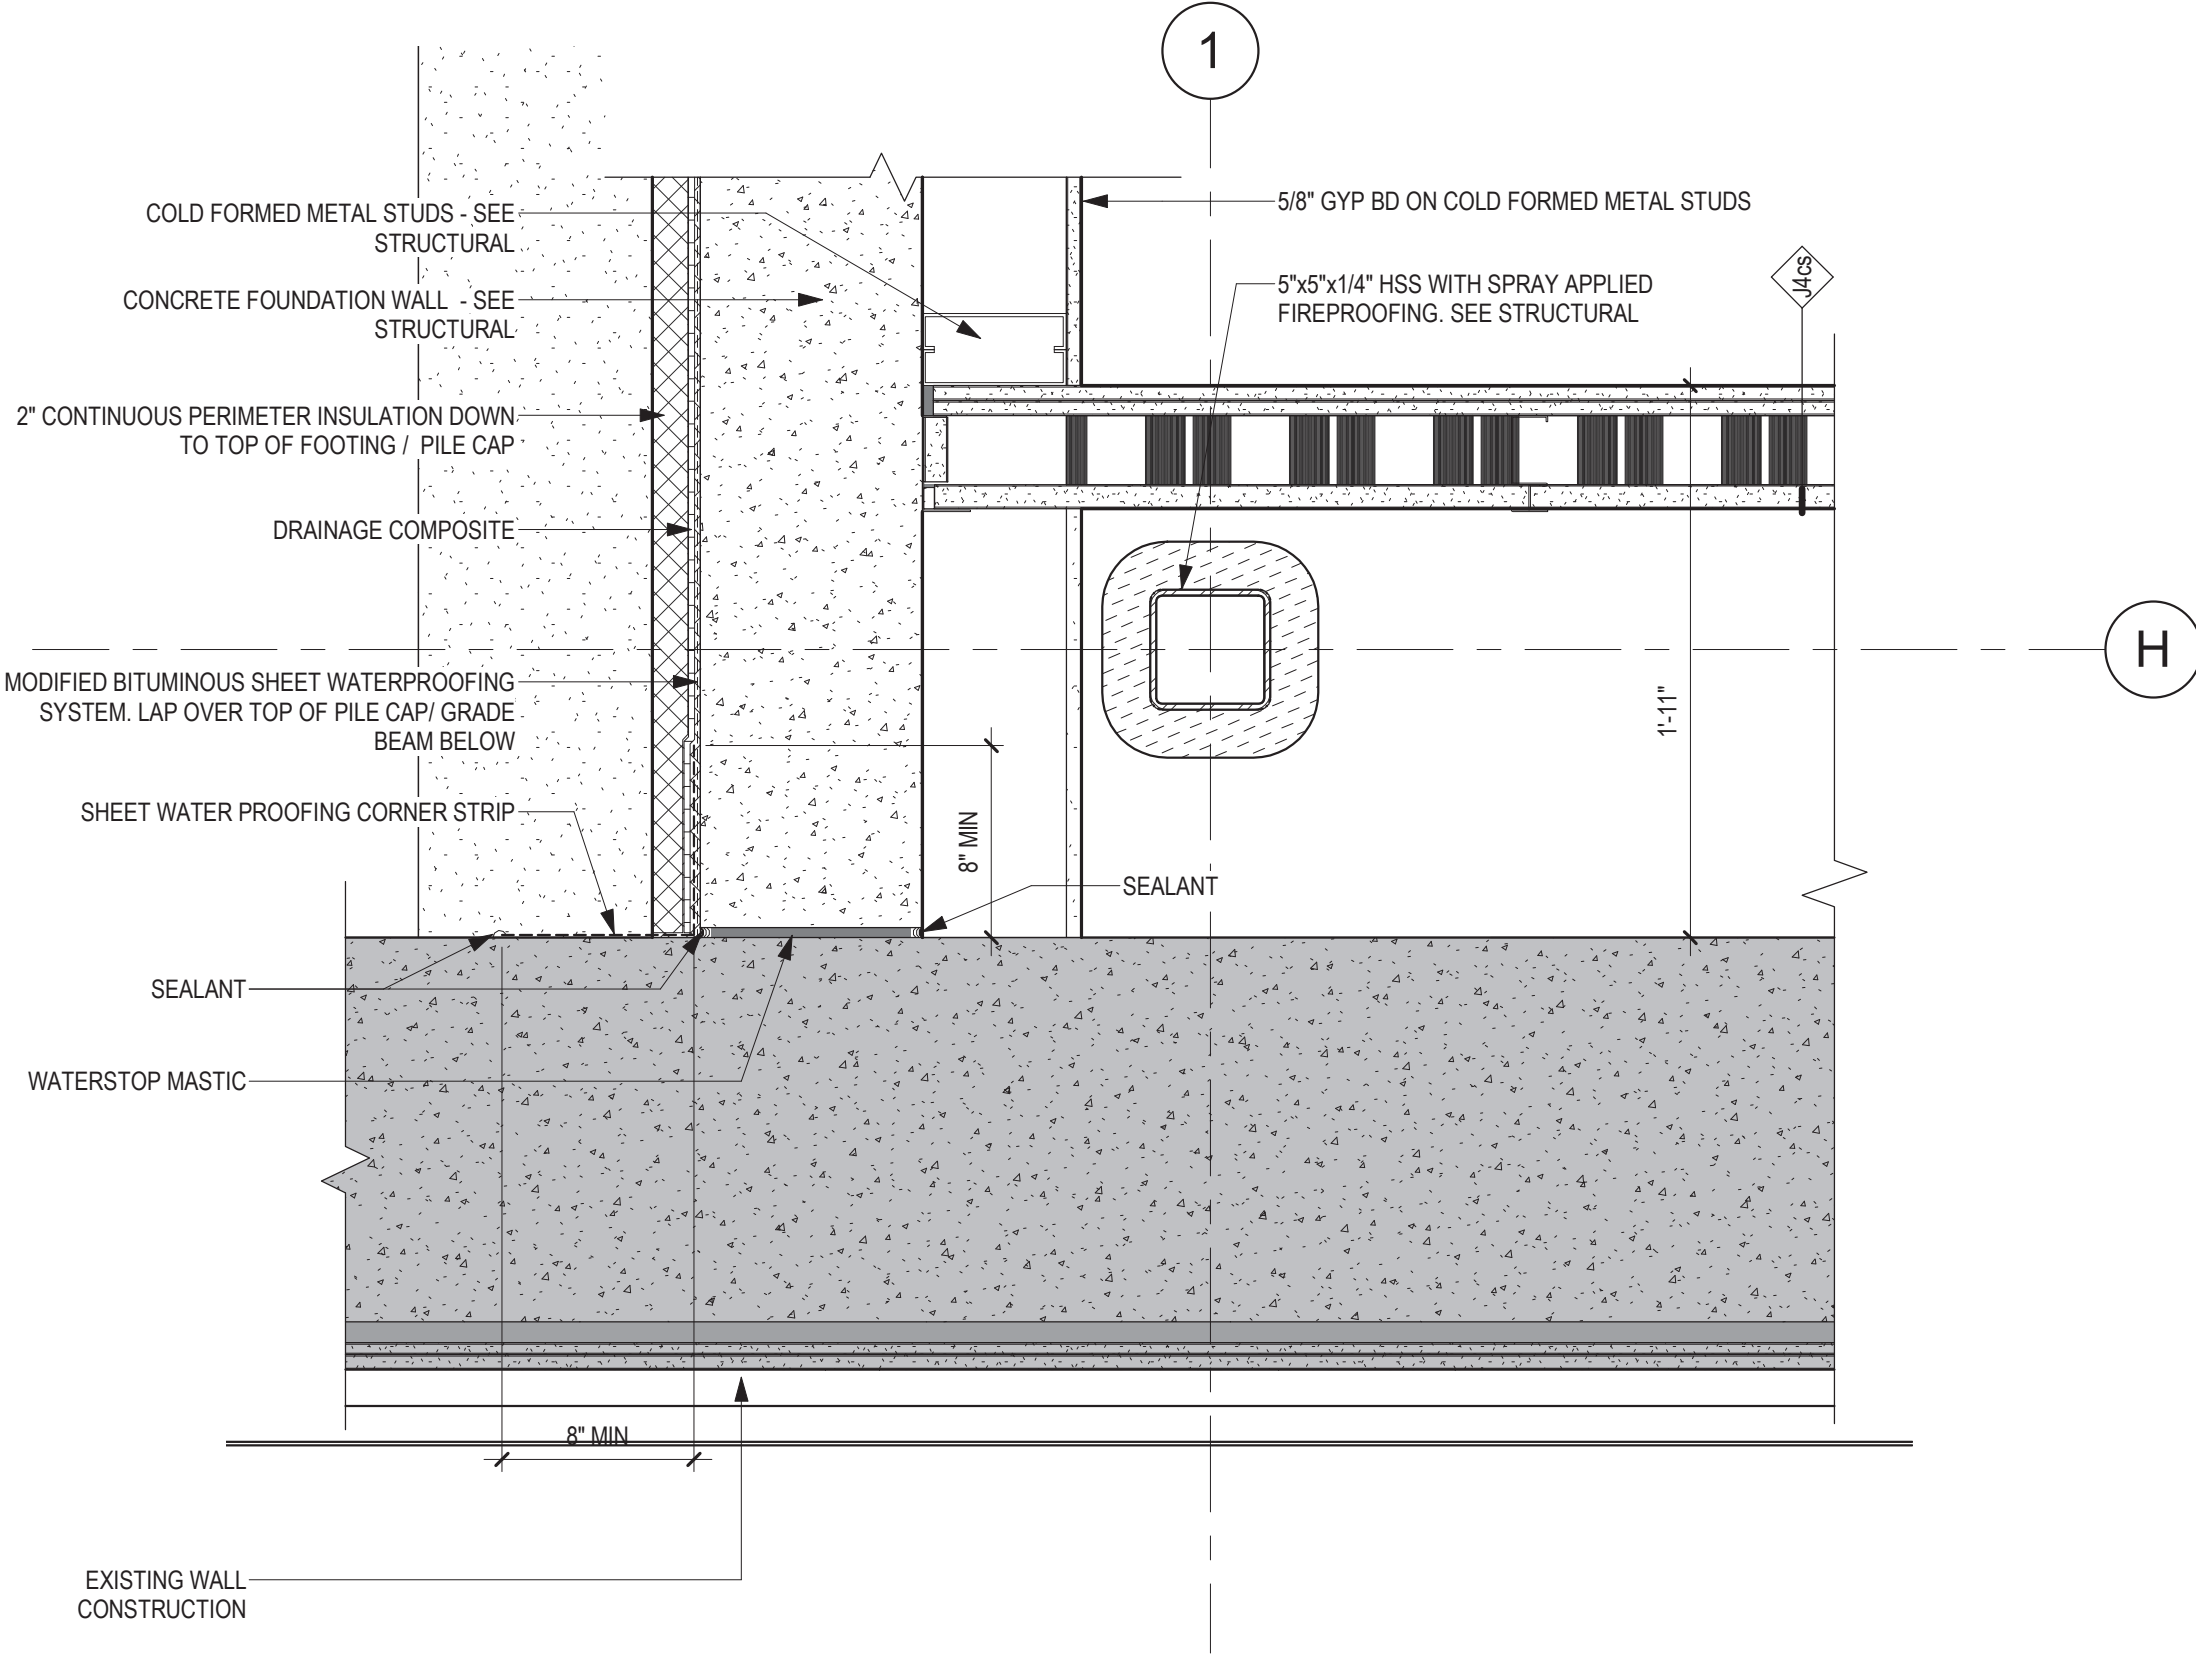


3 PLAN DETAIL - CAST IN PLACE CONCRETE TO EXTING OR EXTERIOR WALL
1 1/2" = 1'-0"

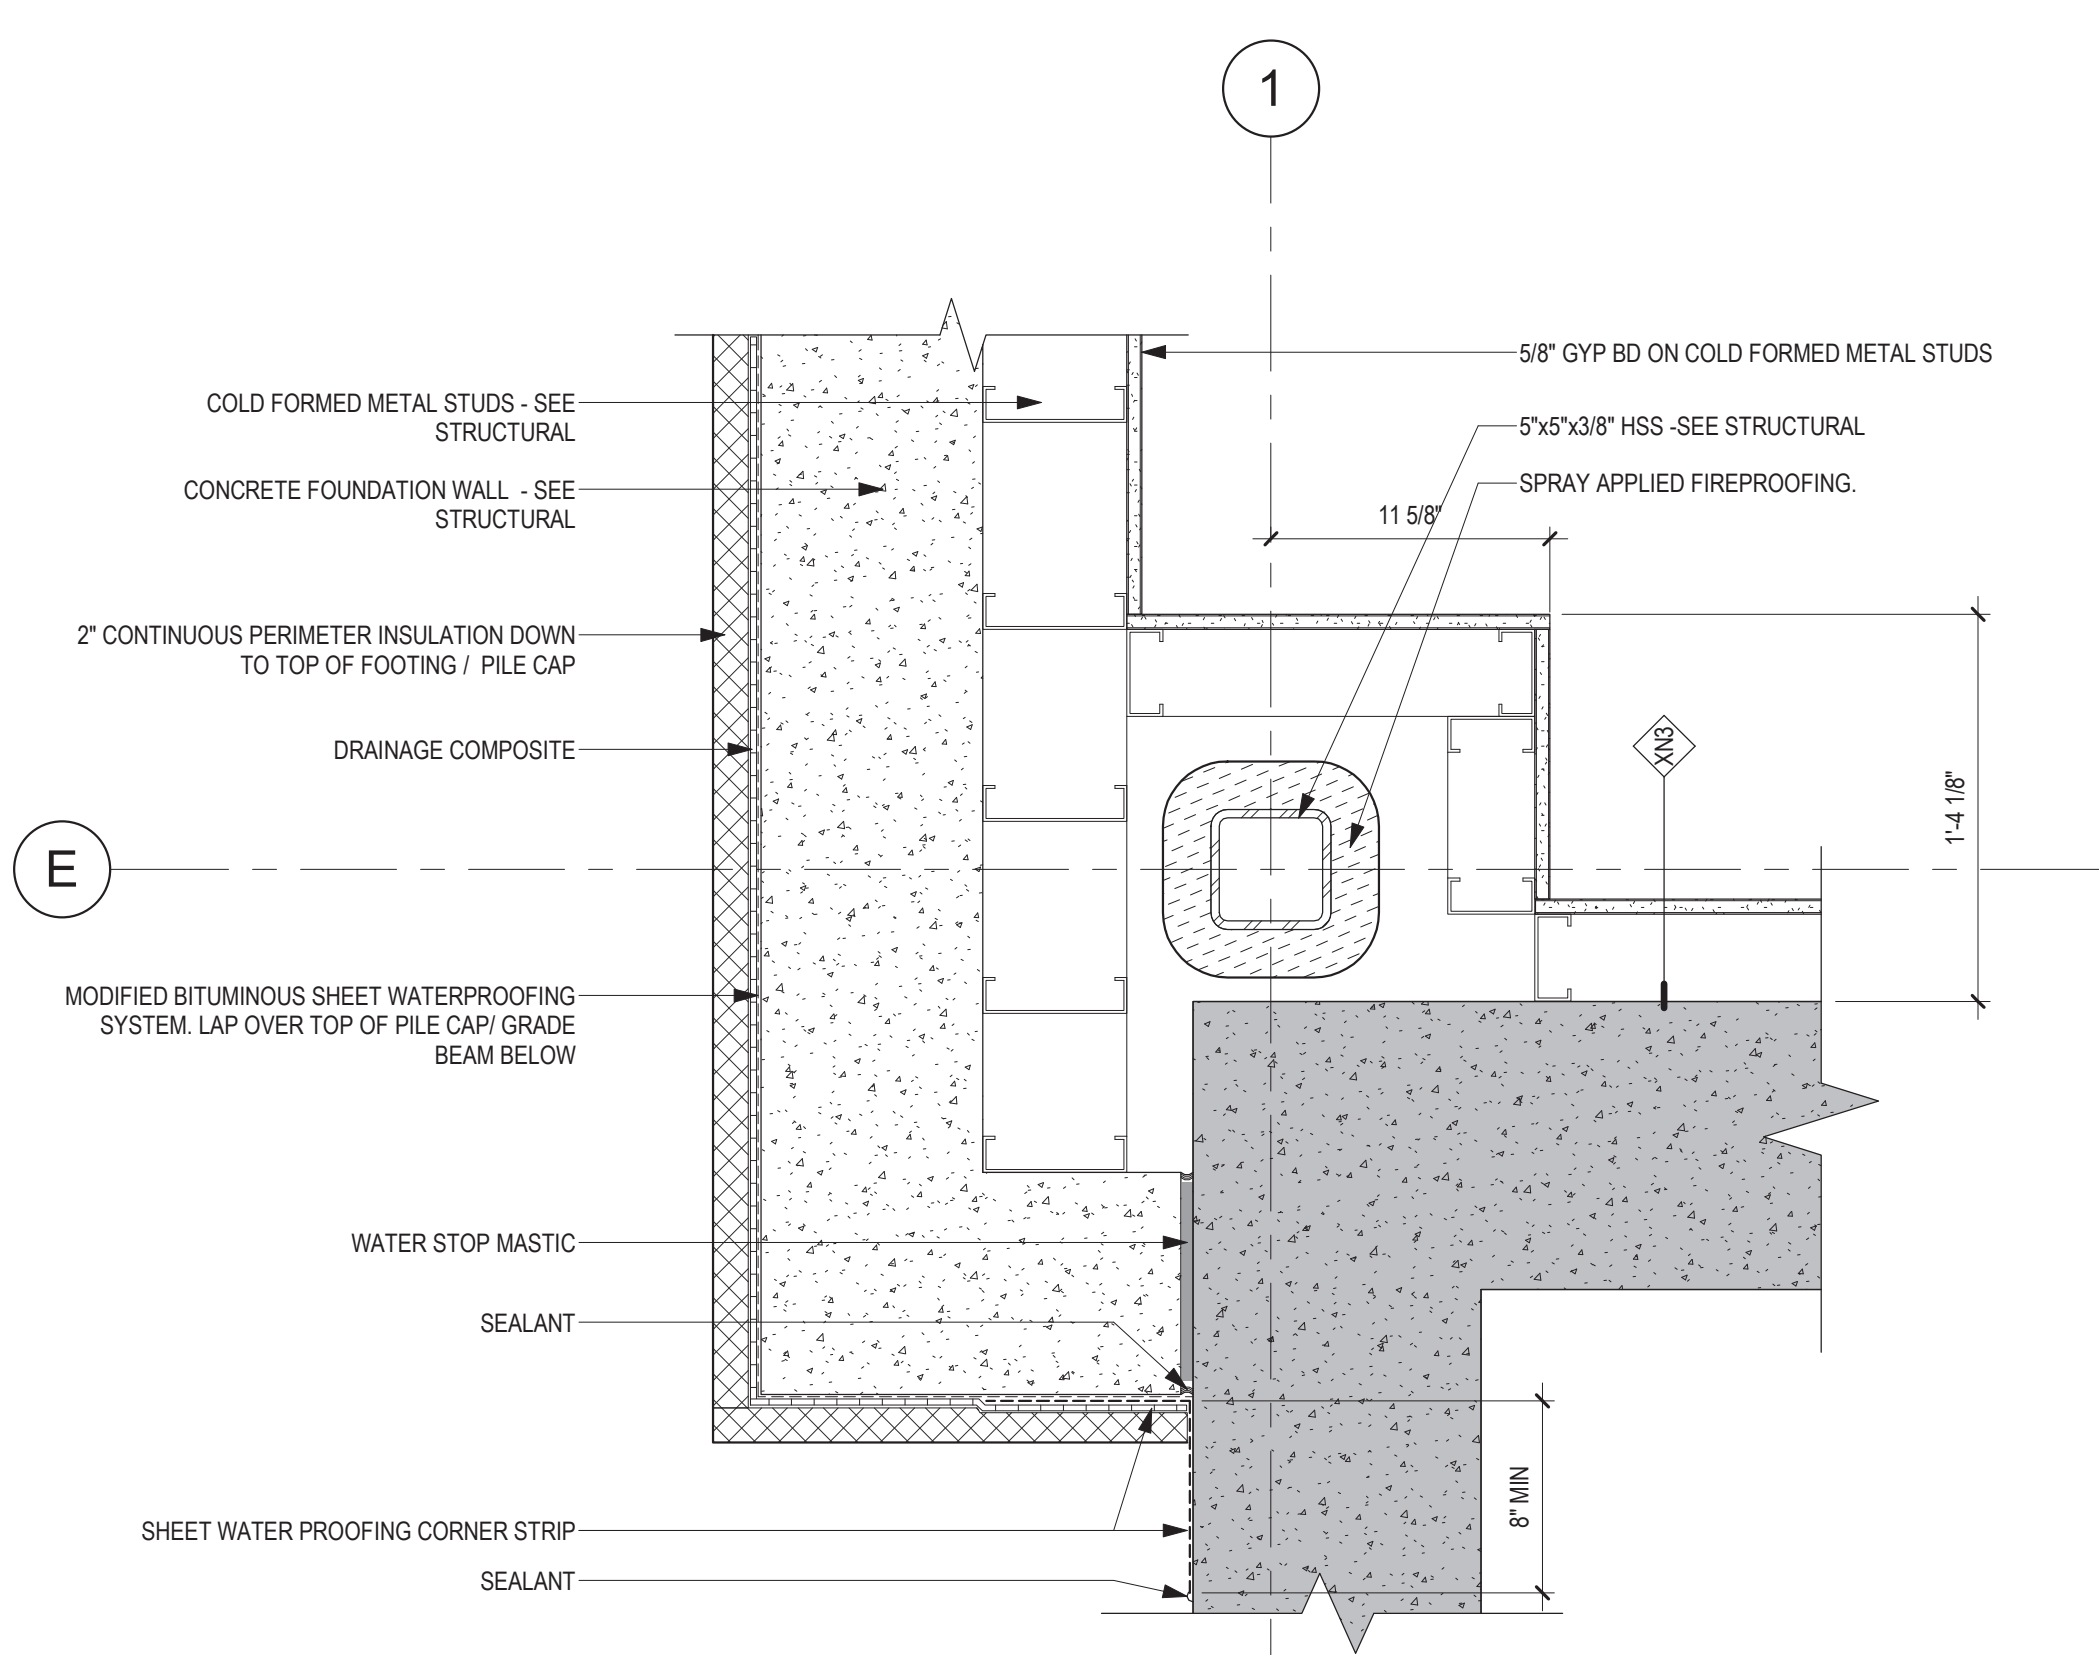


2 PLAN DETAIL - CAST IN PLACE CONCRETE FOUNDATION TO EXISTING STAIR TOWER
1 1/2" = 1'-0"

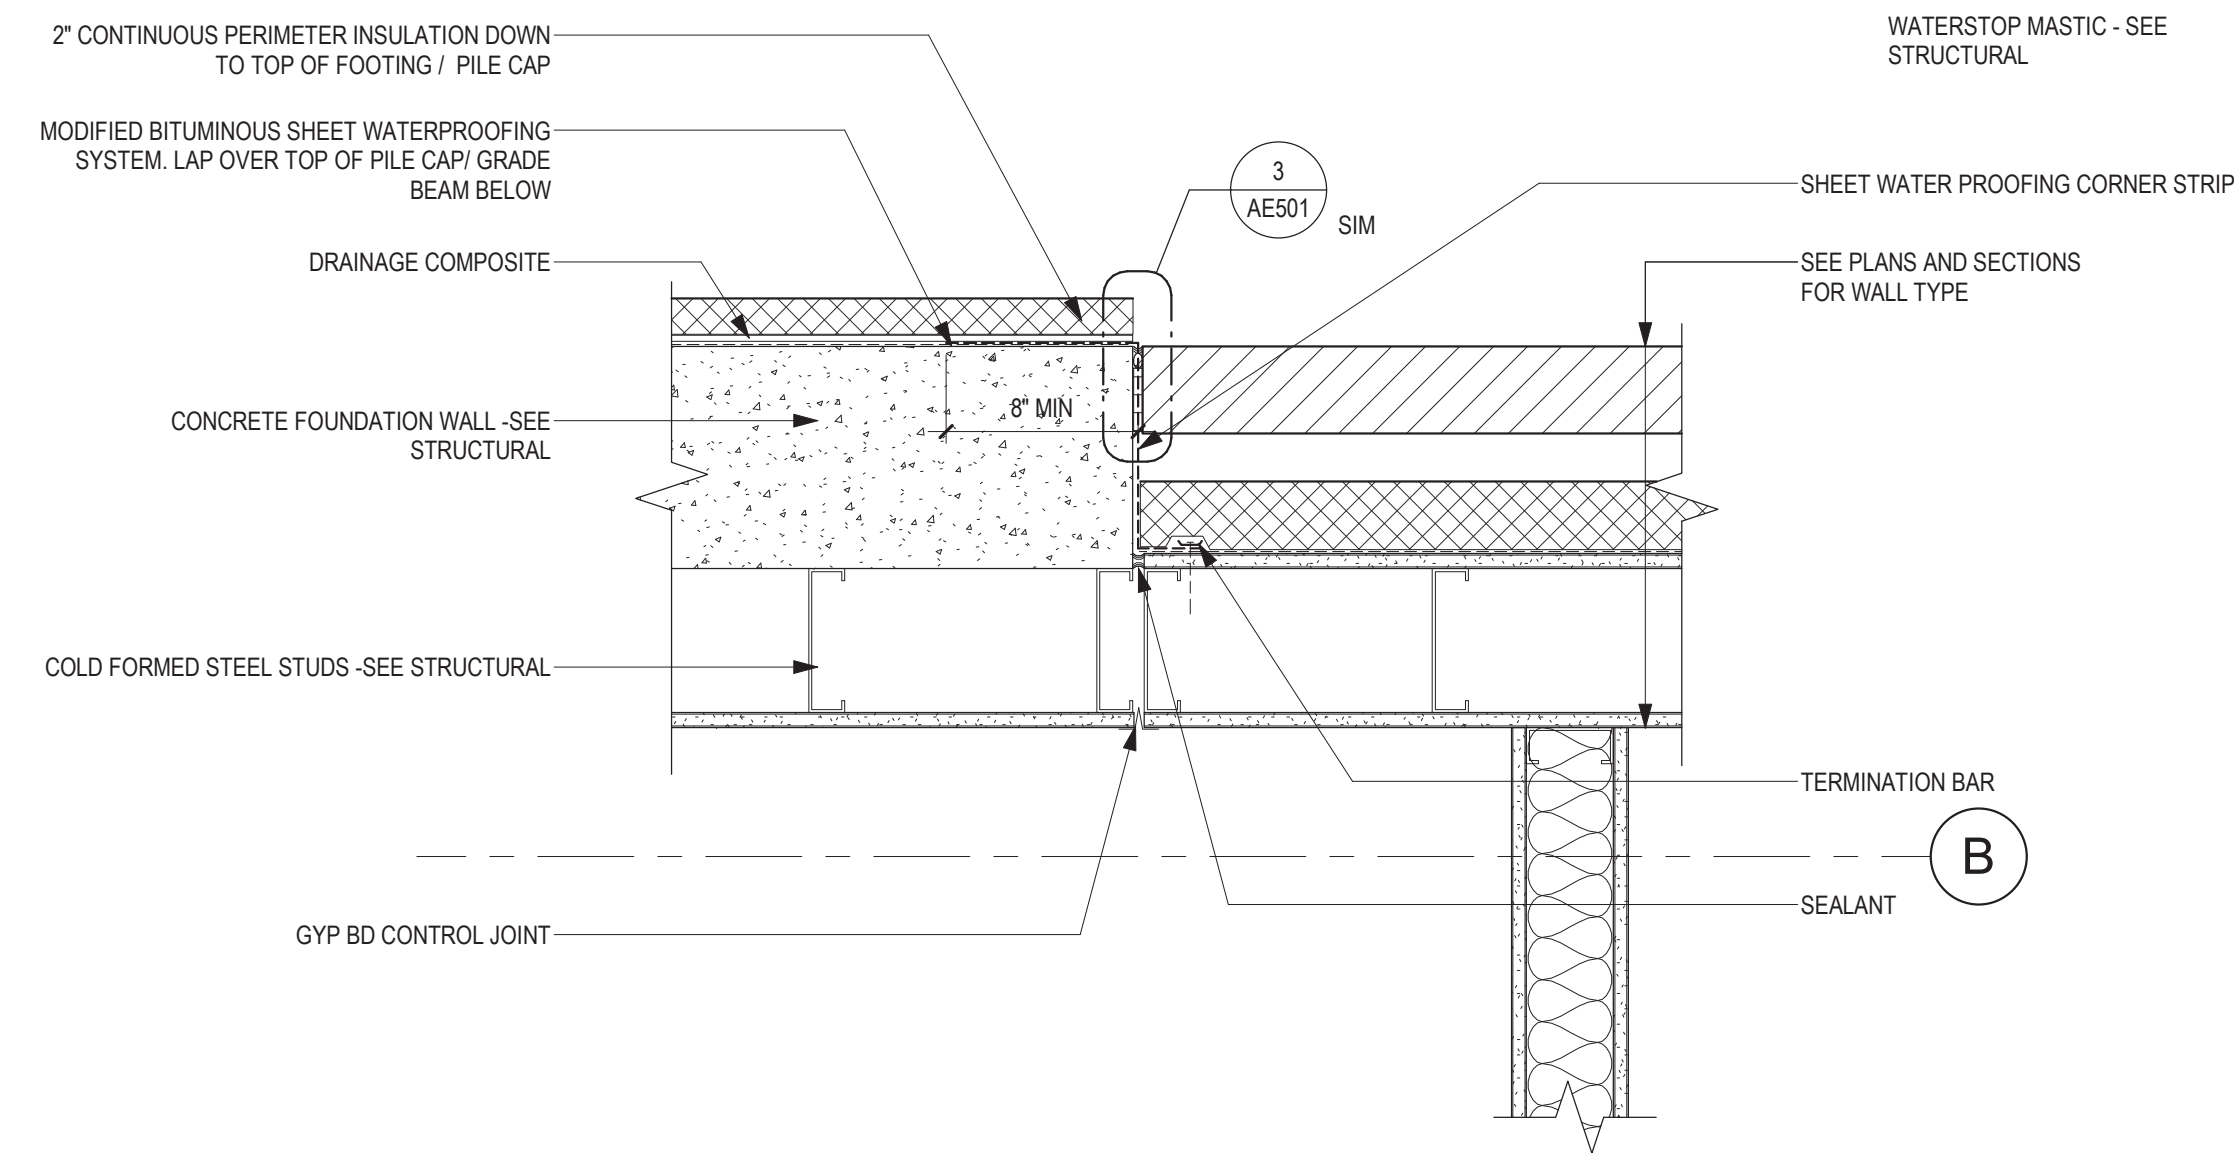


1 PLAN DETAIL - BRICK AND STEEL STUD TO CAST IN PLACE CONCRETE TRANSITION
1 1/2" = 1'-0"

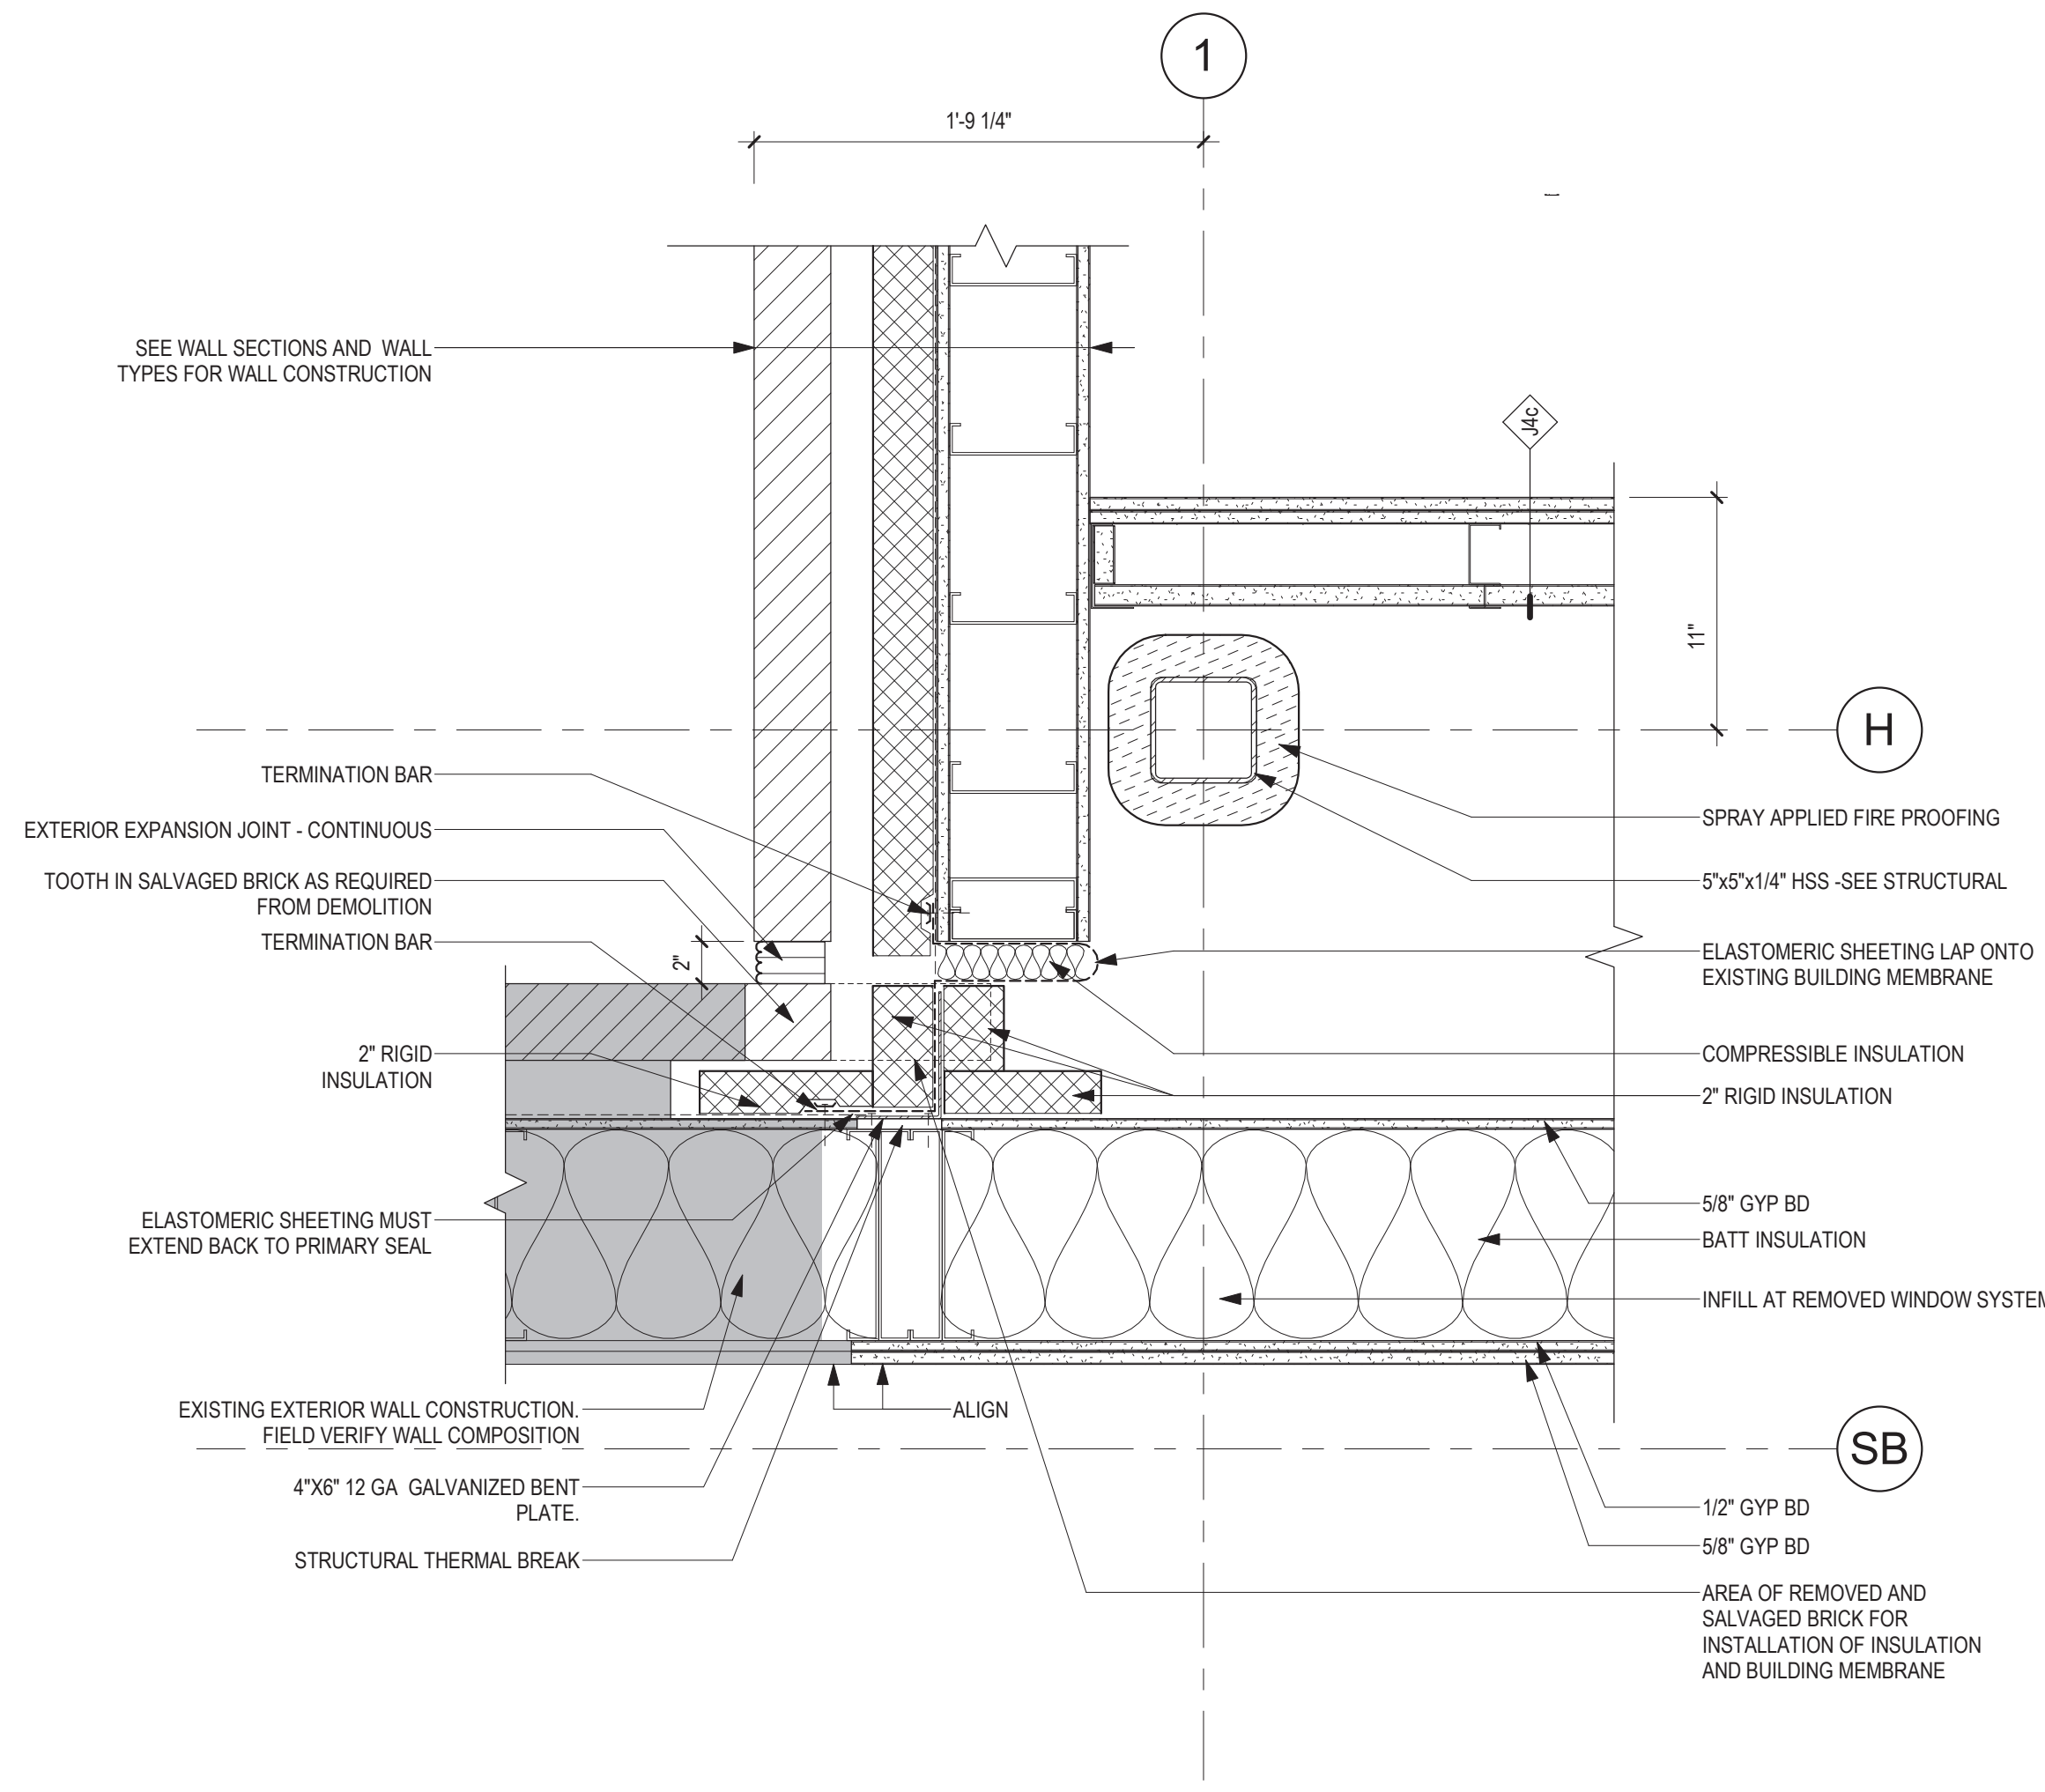

6 PLAN DETAIL -BRICK AND STEEL STUDS TO EXTING 'OPERATING SUITE' EXTERIOR WALL
1 1/2" = 1'-0"


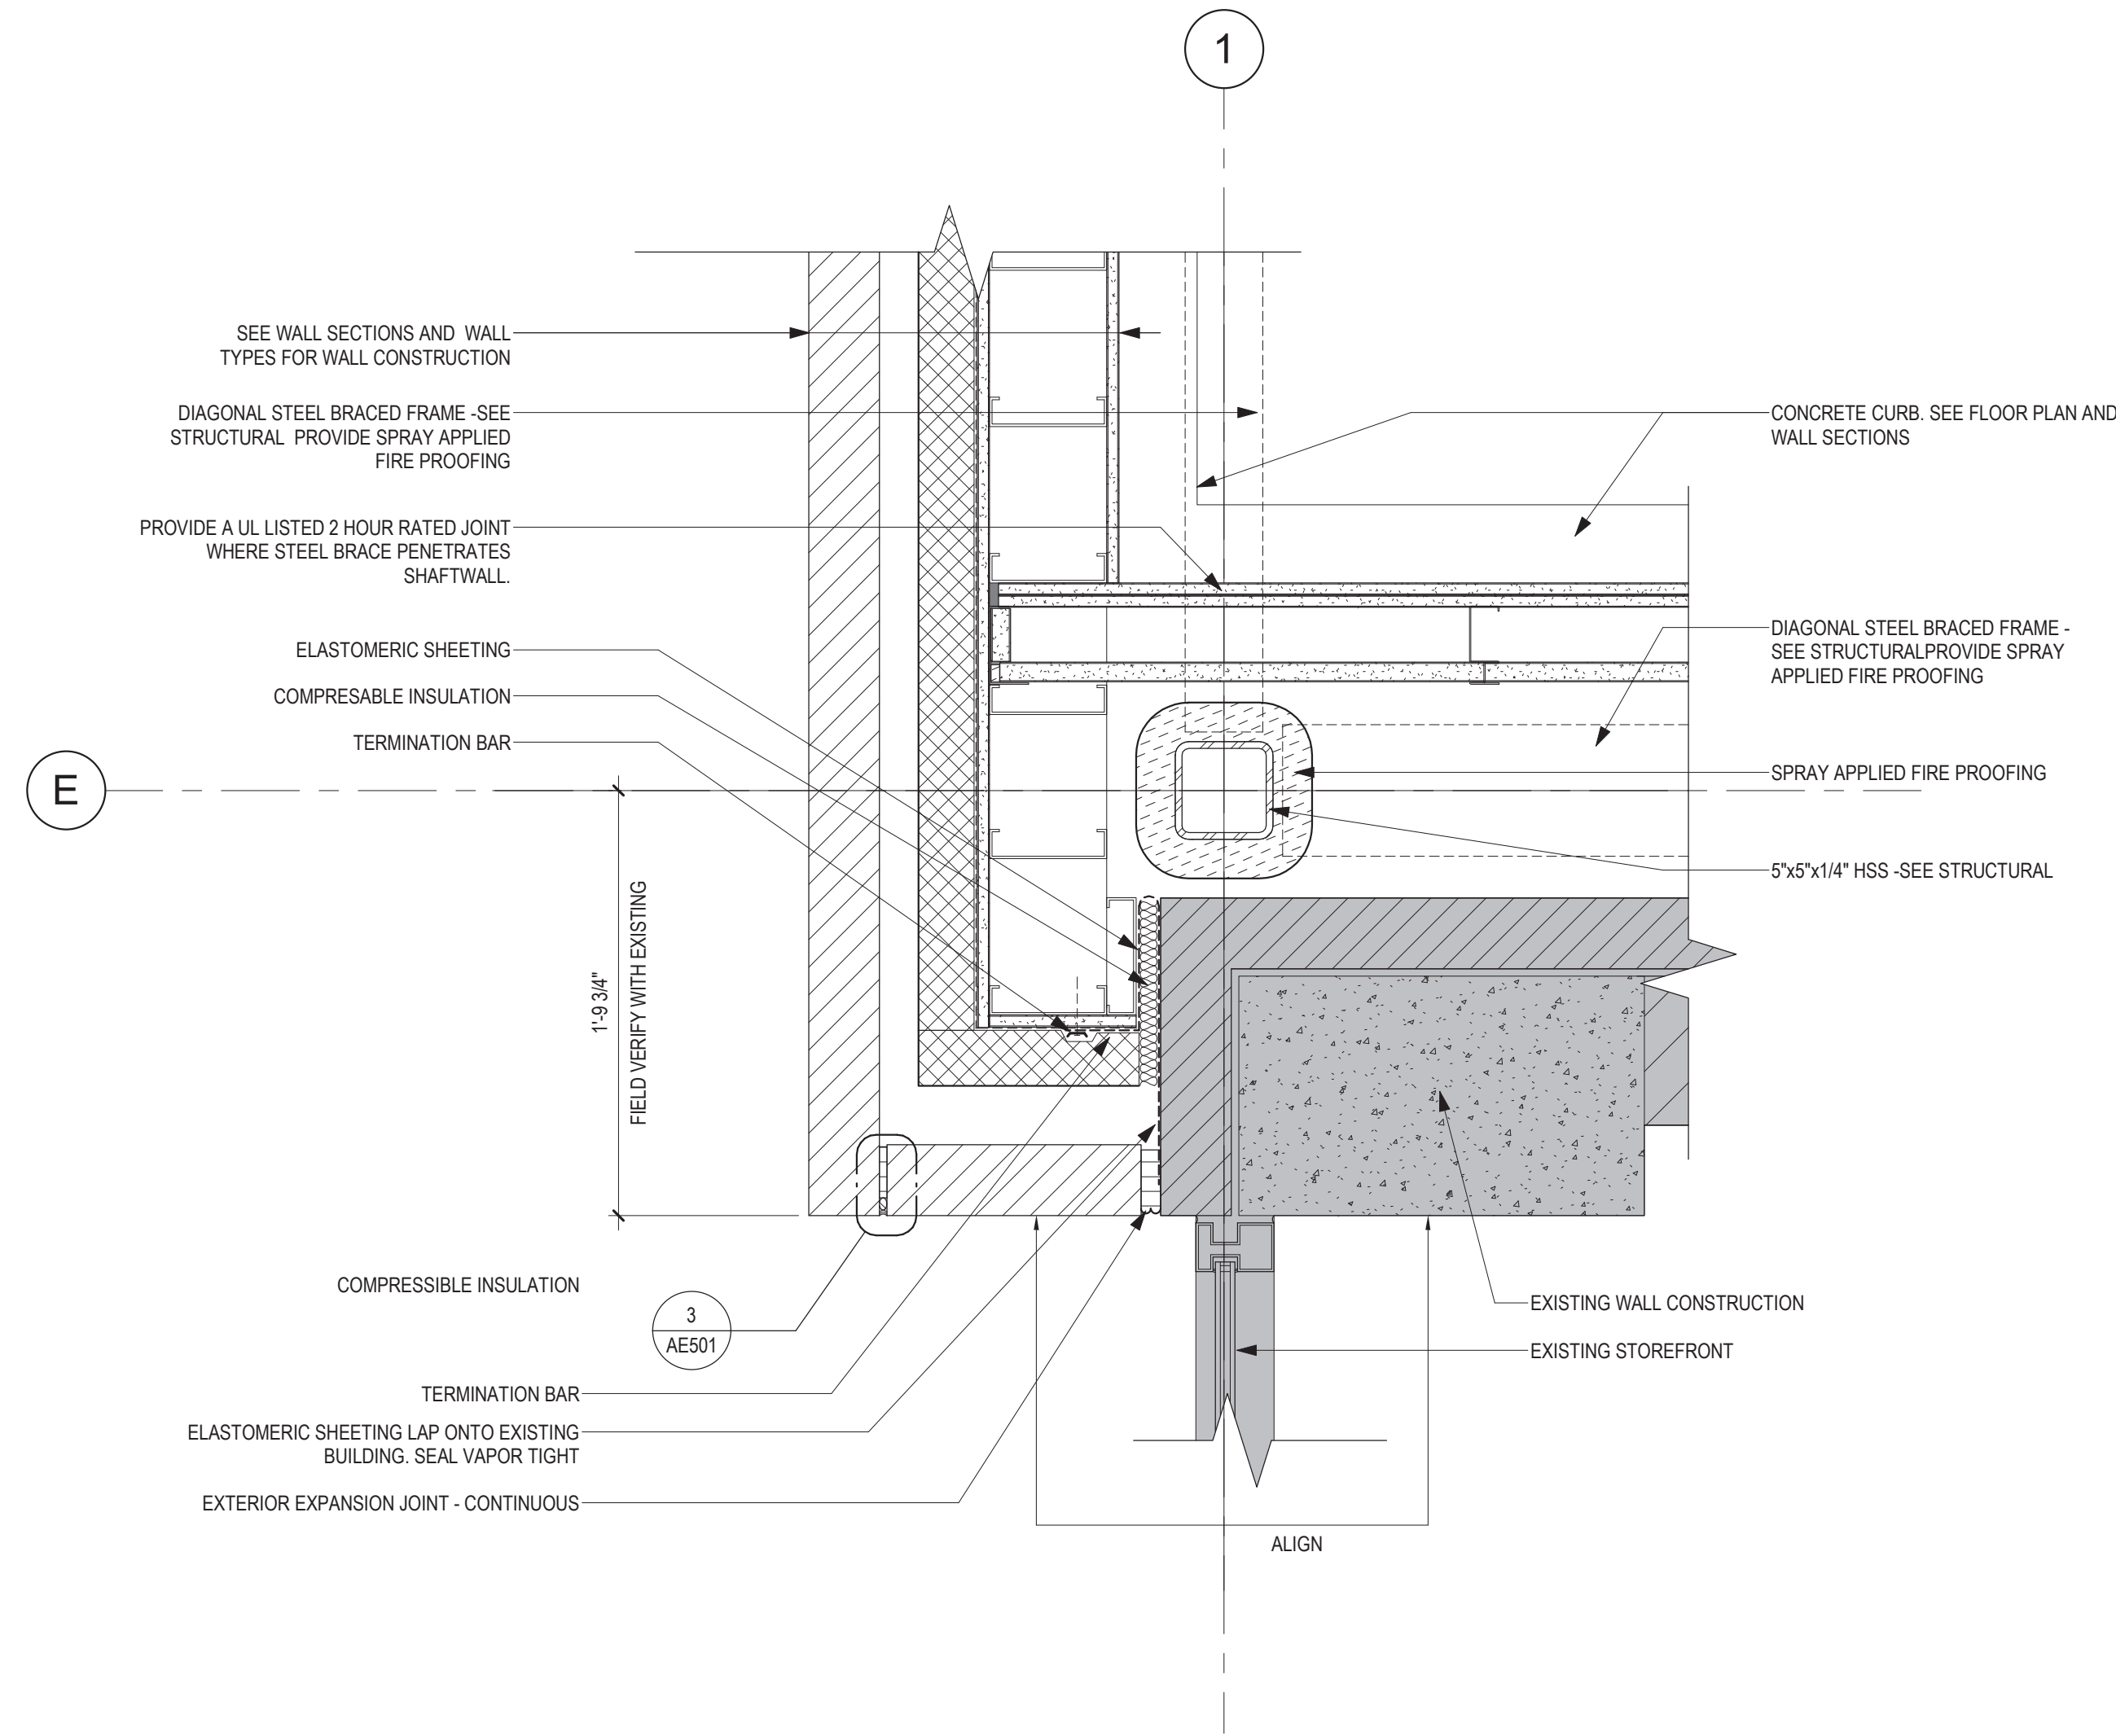


5 PLAN DETAIL - BRICK AND STEEL STUD AT EXISTING STAIR TOWER - INTERSTITIAL 134
1 1/2" = 1'-0"

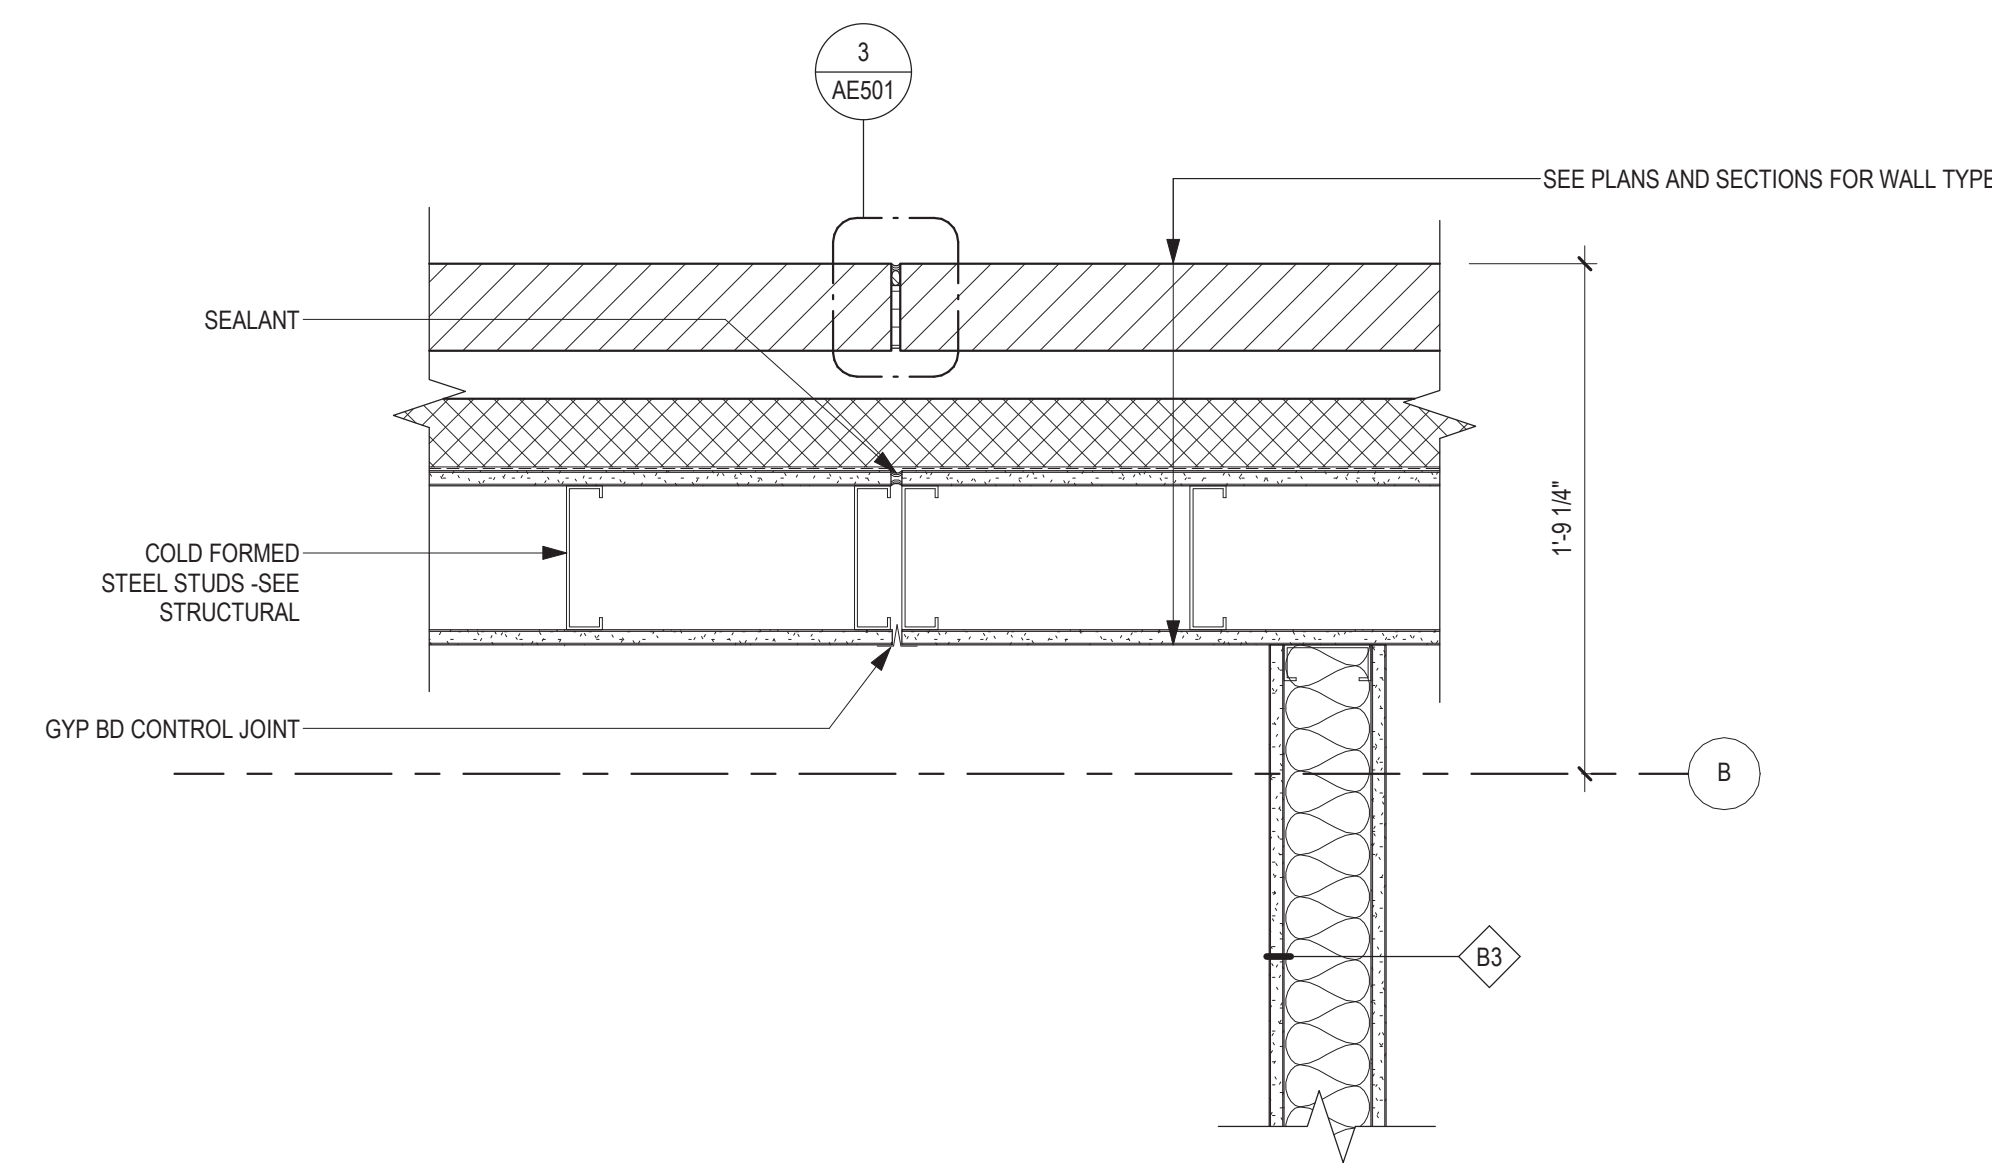

4 PLAN DETAIL - BRICK AND STEEL STUD ABOVE CAST IN PLACE CONCRETE TRANSITION
1 1/2" = 1'-0"

Revisions:	Date:

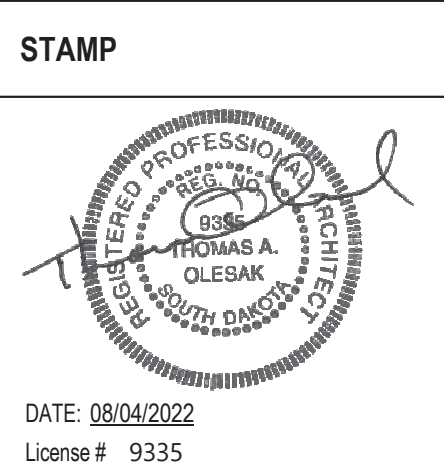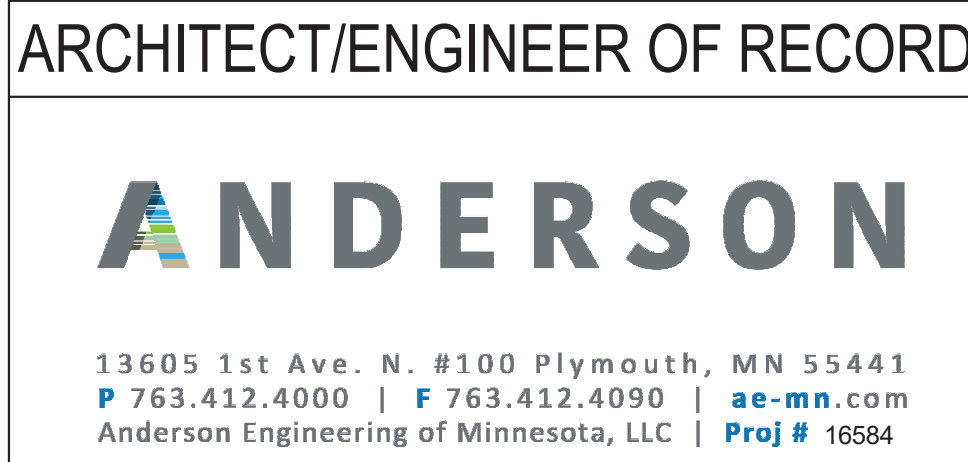


Drawing Title
EXTERIOR PLAN DETAILS
Approved:

Phase
BID DOCUMENTS
FULLY SPRINKLERED

Project Title
CONSTRUCT NEW SPS
Location
Sioux Falls, SD.
Issue Date
08/04/2022
Checked
Checker
Drawn
Author

Project Number
438-460
Building Number
5
Drawing Number
AE502

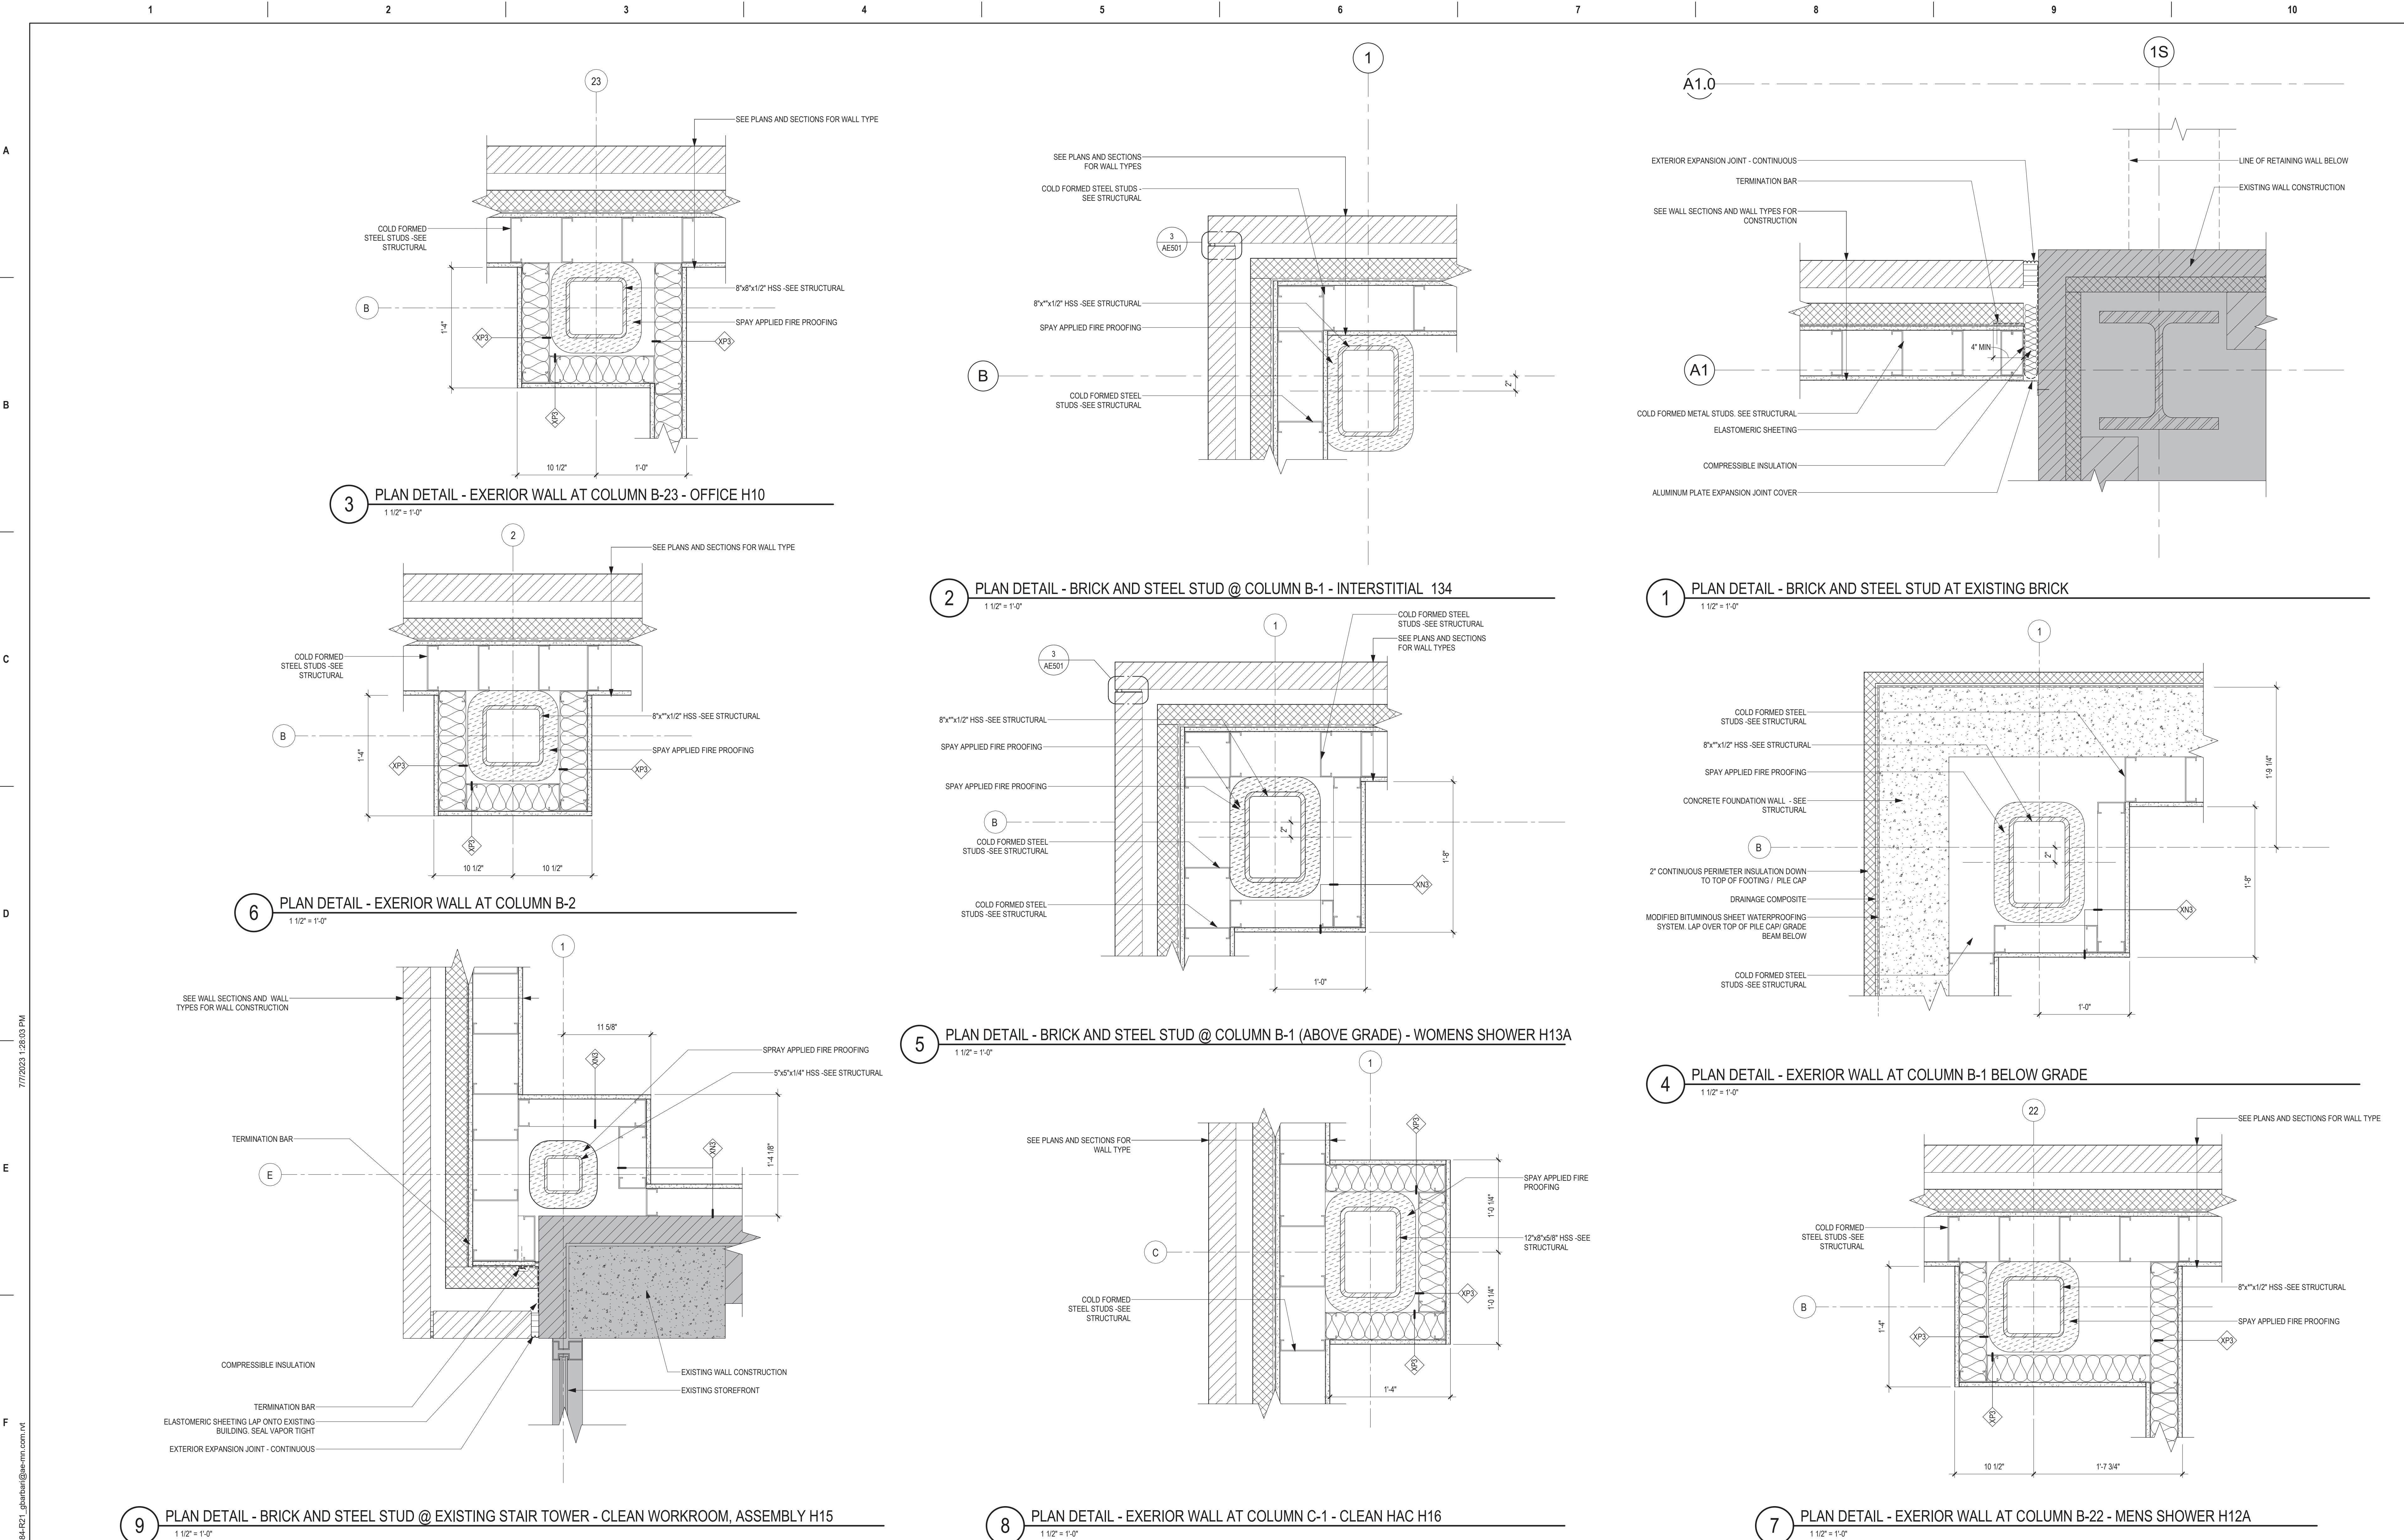

Revisions:	Date:

CONSULTANT

ARCHITECT/ENGINEER OF RECORD

13605 1st Ave. N. #100 Plymouth, MN 55441
P 763.412.4000 | F 763.412.4090 | ae-mn.com
Anderson Engineering of Minnesota, LLC | Proj # 16684

STAMP

Office of Construction and Facilities Management

U.S. Department of Veterans Affairs

Drawing Title

EXTERIOR PLAN DETAILS

Approved:

Phase

BID DOCUMENTS

FULLY SPRINKLERED

Project Title

CONSTRUCT NEW SPS

Location
Sioux Falls, SD.

Issue Date
08/04/2022

Checked
Checker

Drawn
Author

Project Number
438-460

Building Number
5

Drawing Number
AE503

A

B

C


D

E


F

7/7/2023 1:28:06 PM


C:\Users\Public\Documents\Revit Projects\6554-R21_gbarani@ae-mm.com.rvt

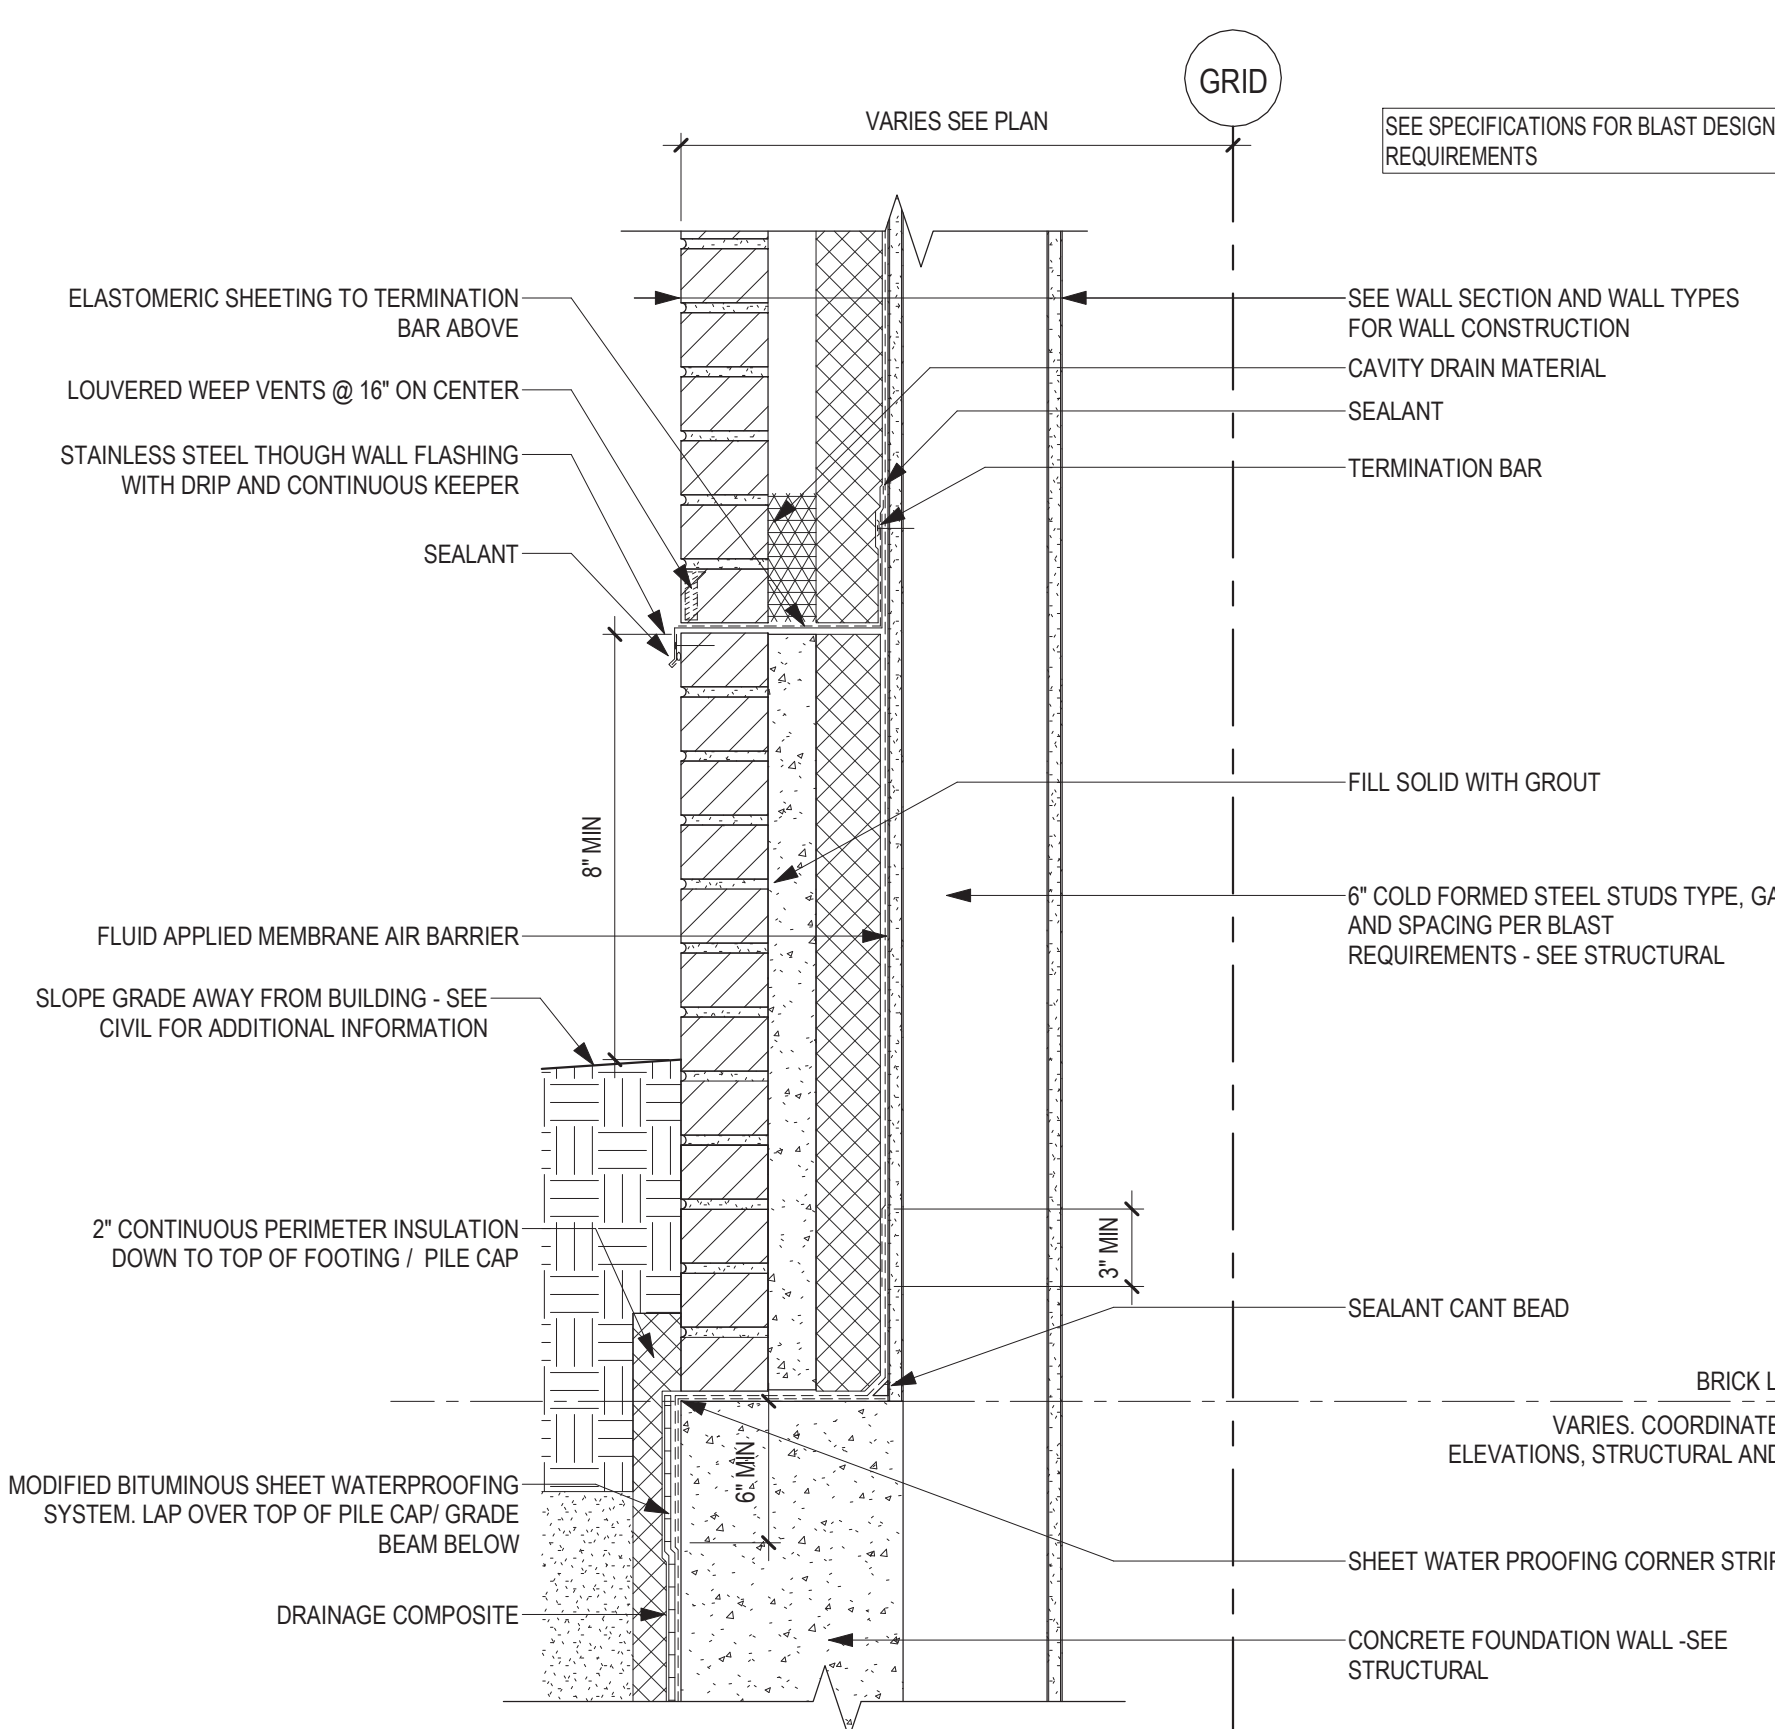


2 SECTION DETAIL - FACEBRICK AND METAL STUD AT GRADE
1 1/2" = 1'-0"

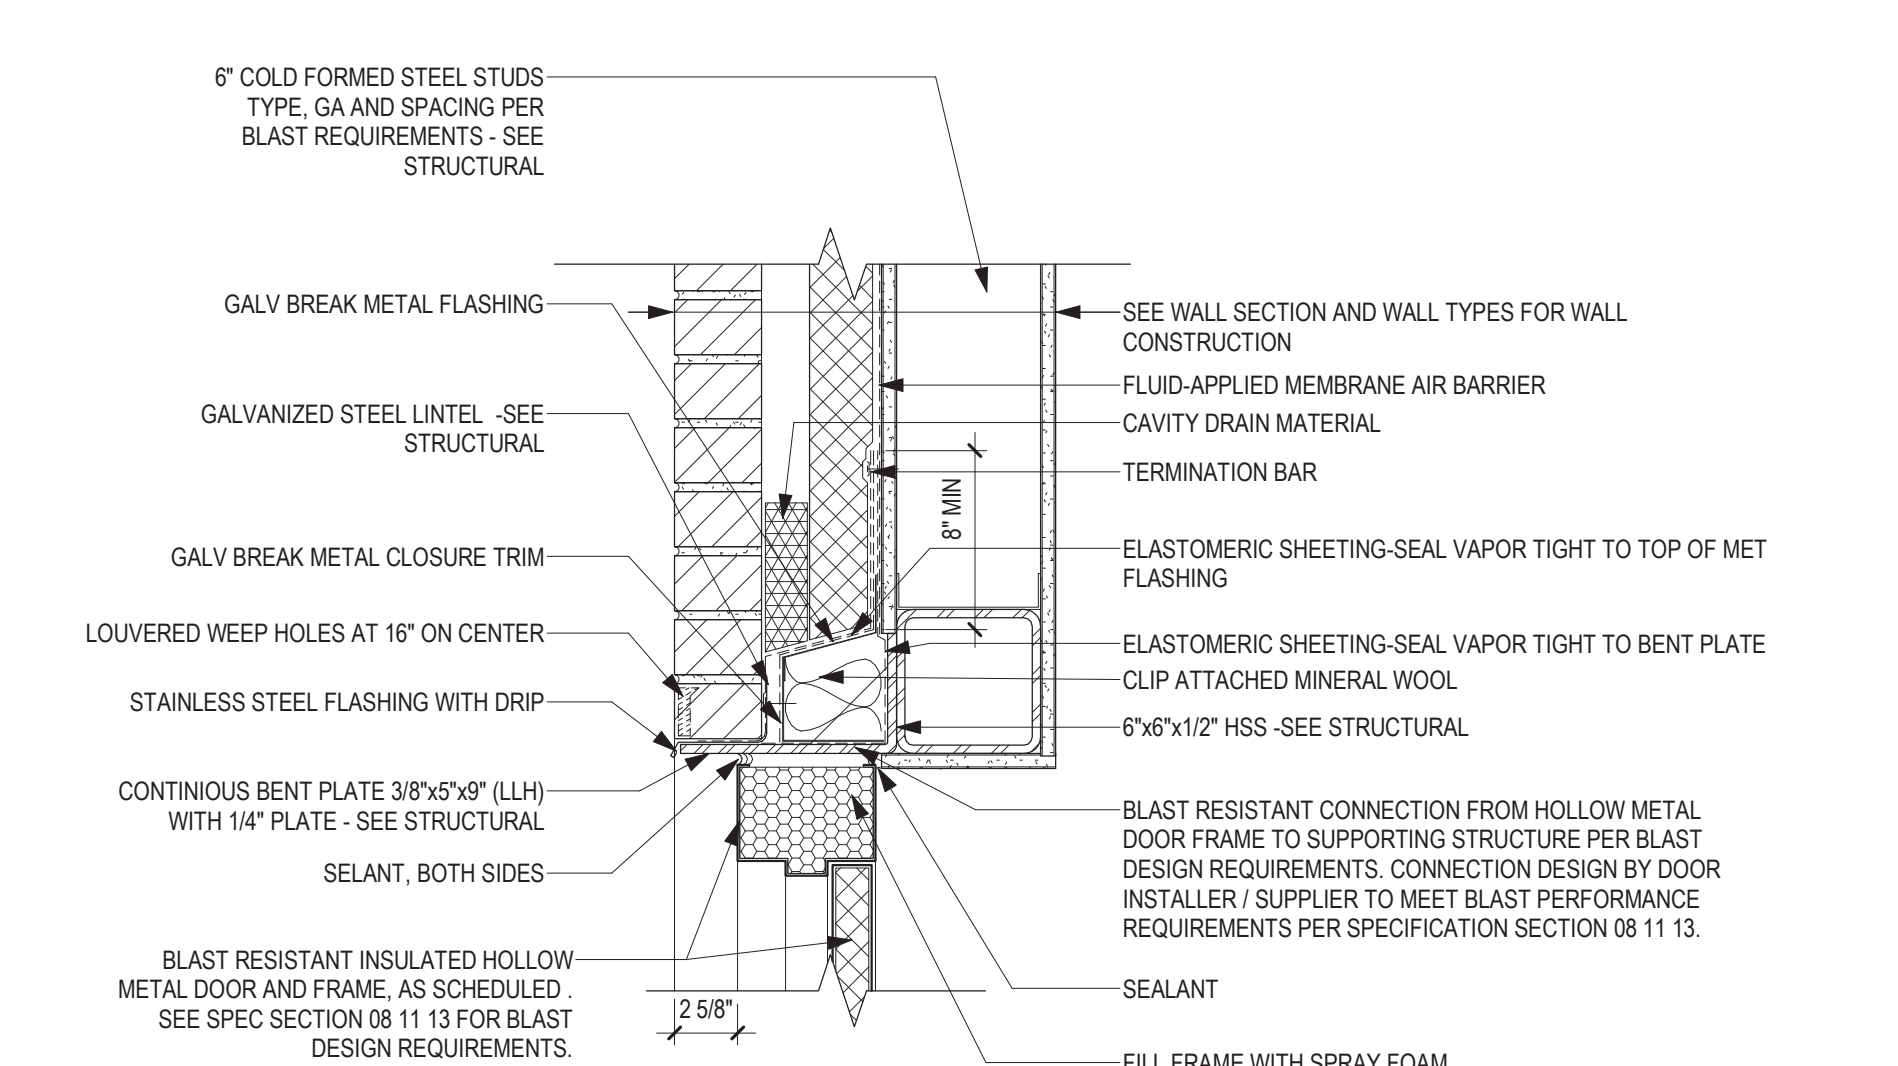


4 SECTION DETAIL - HM FRAME HEAD AT METAL STUD BACK UP AND FACE BRICK
1 1/2" = 1'-0"

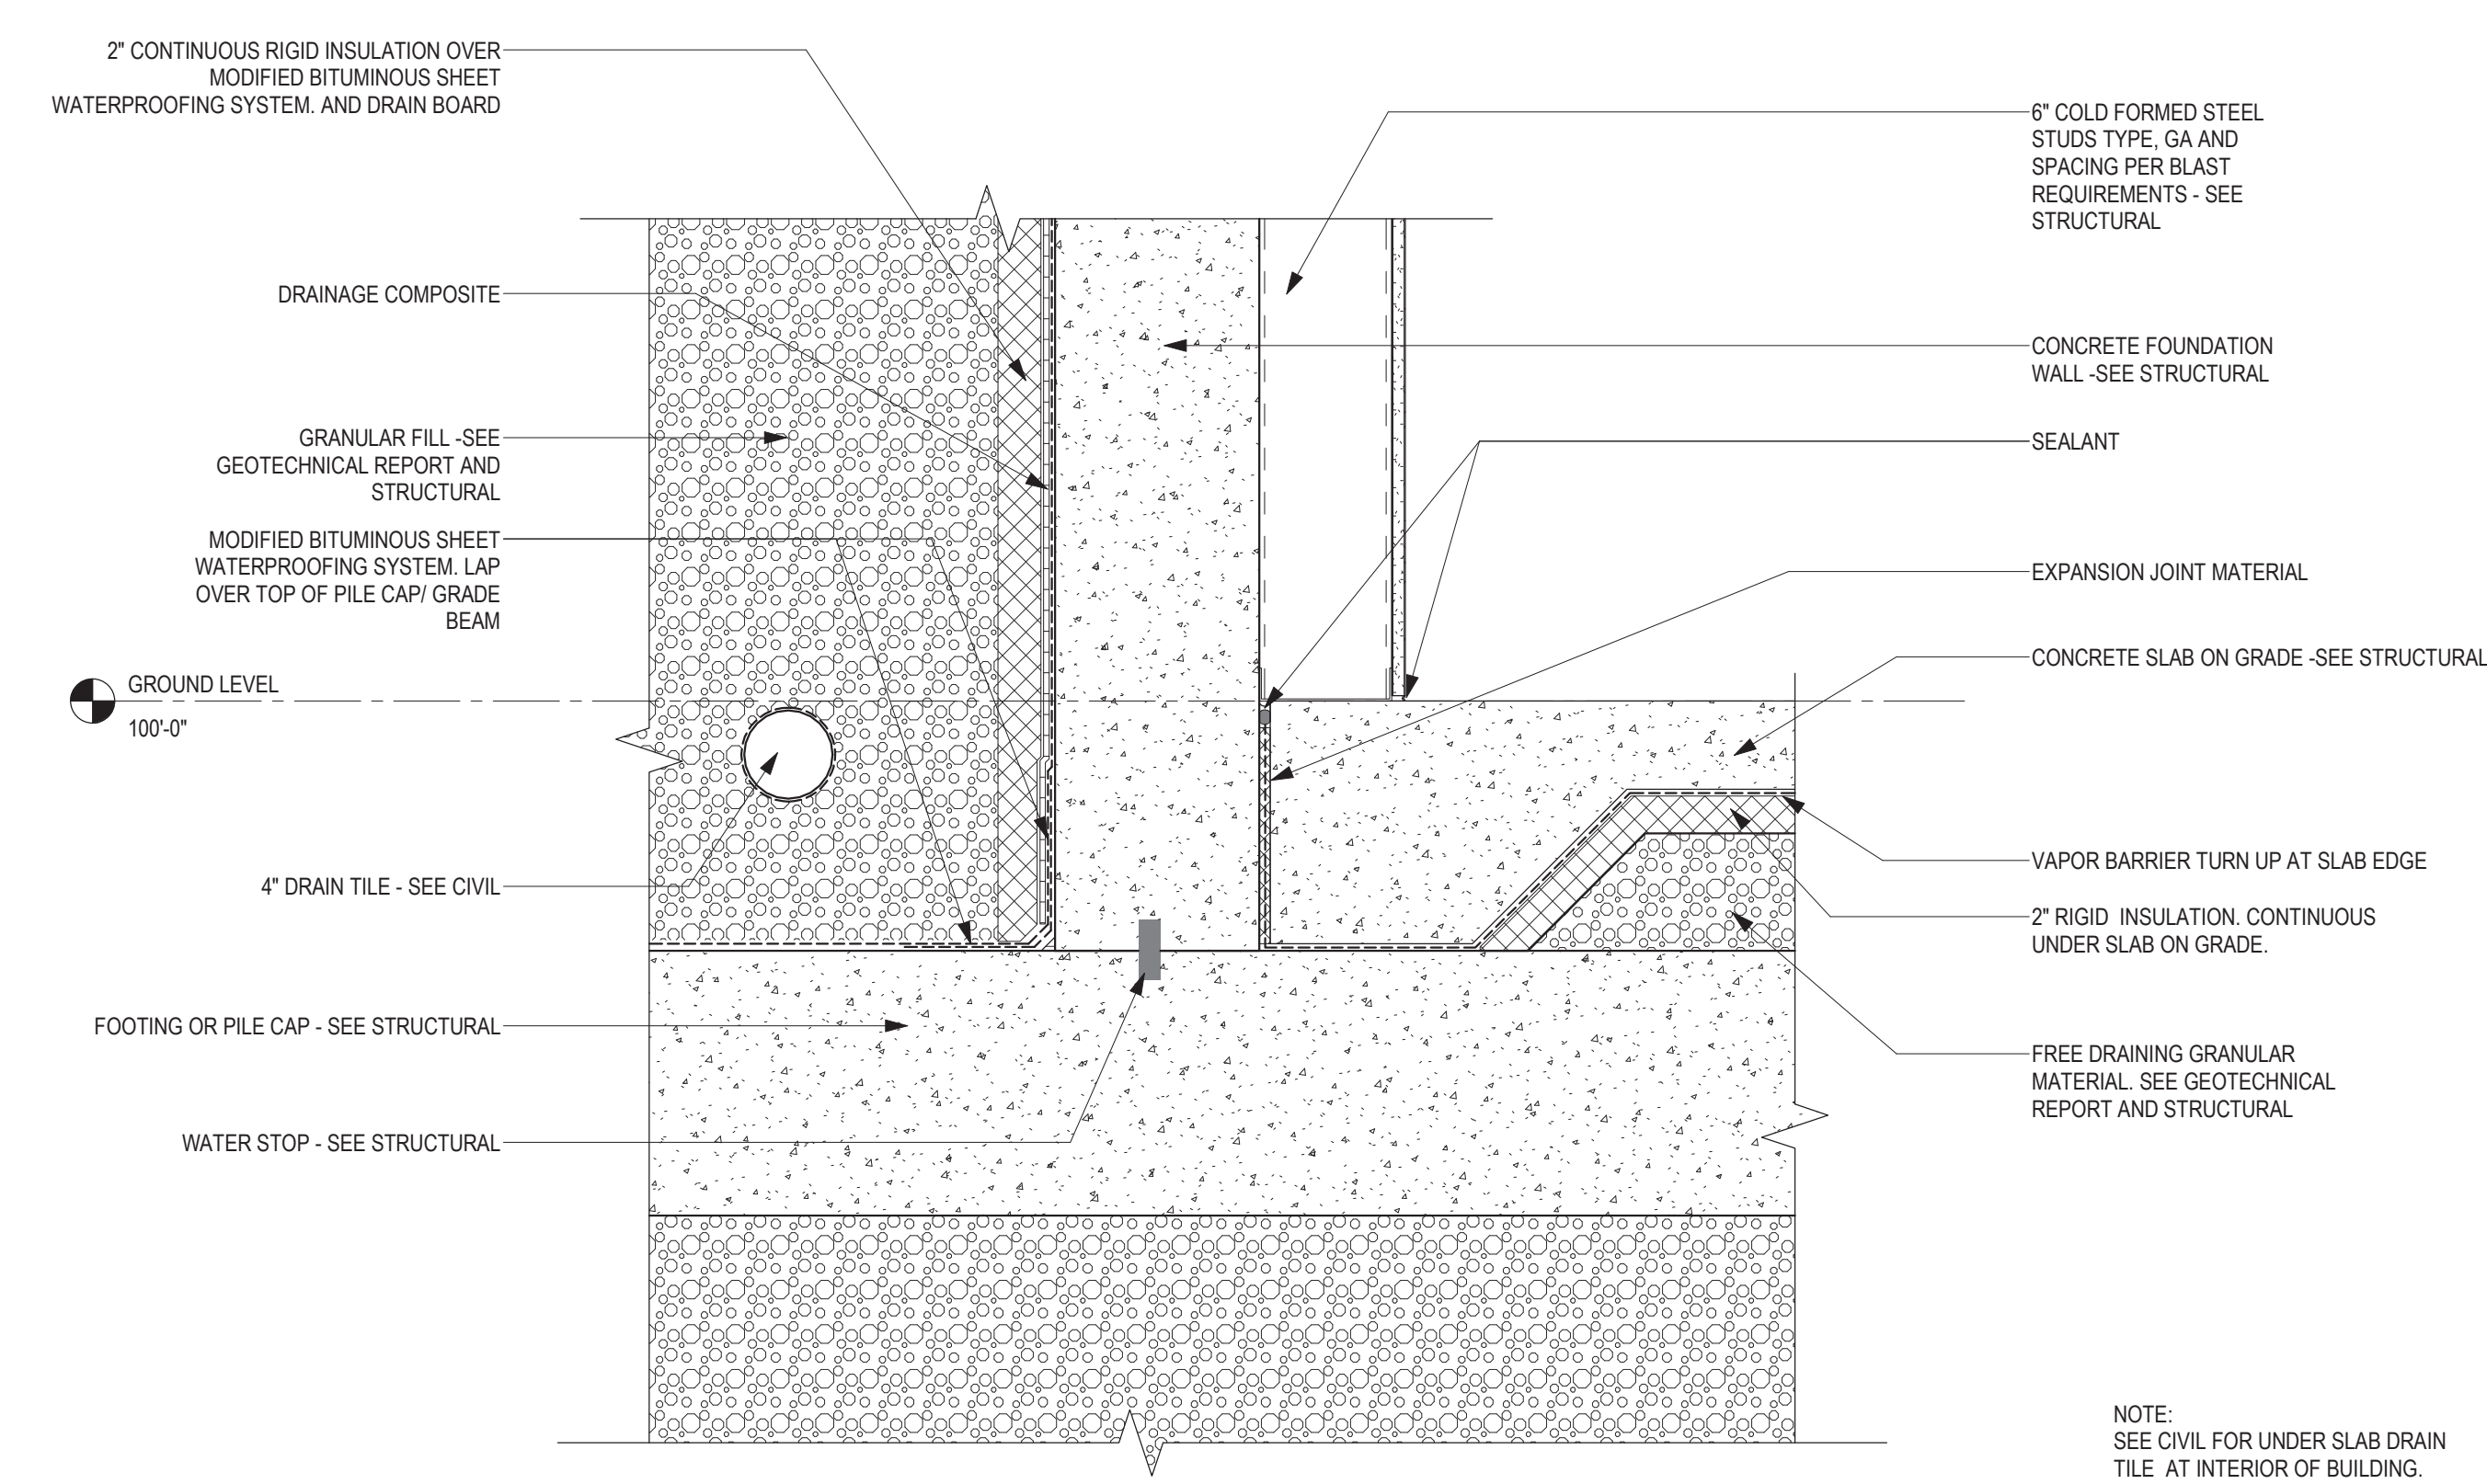


7 SECTION DETAIL - GRADE BEAM / PILE CAP AND FOUNDATION WALL WATERPROOFING (TYP)
1 1/2" = 1'-0"

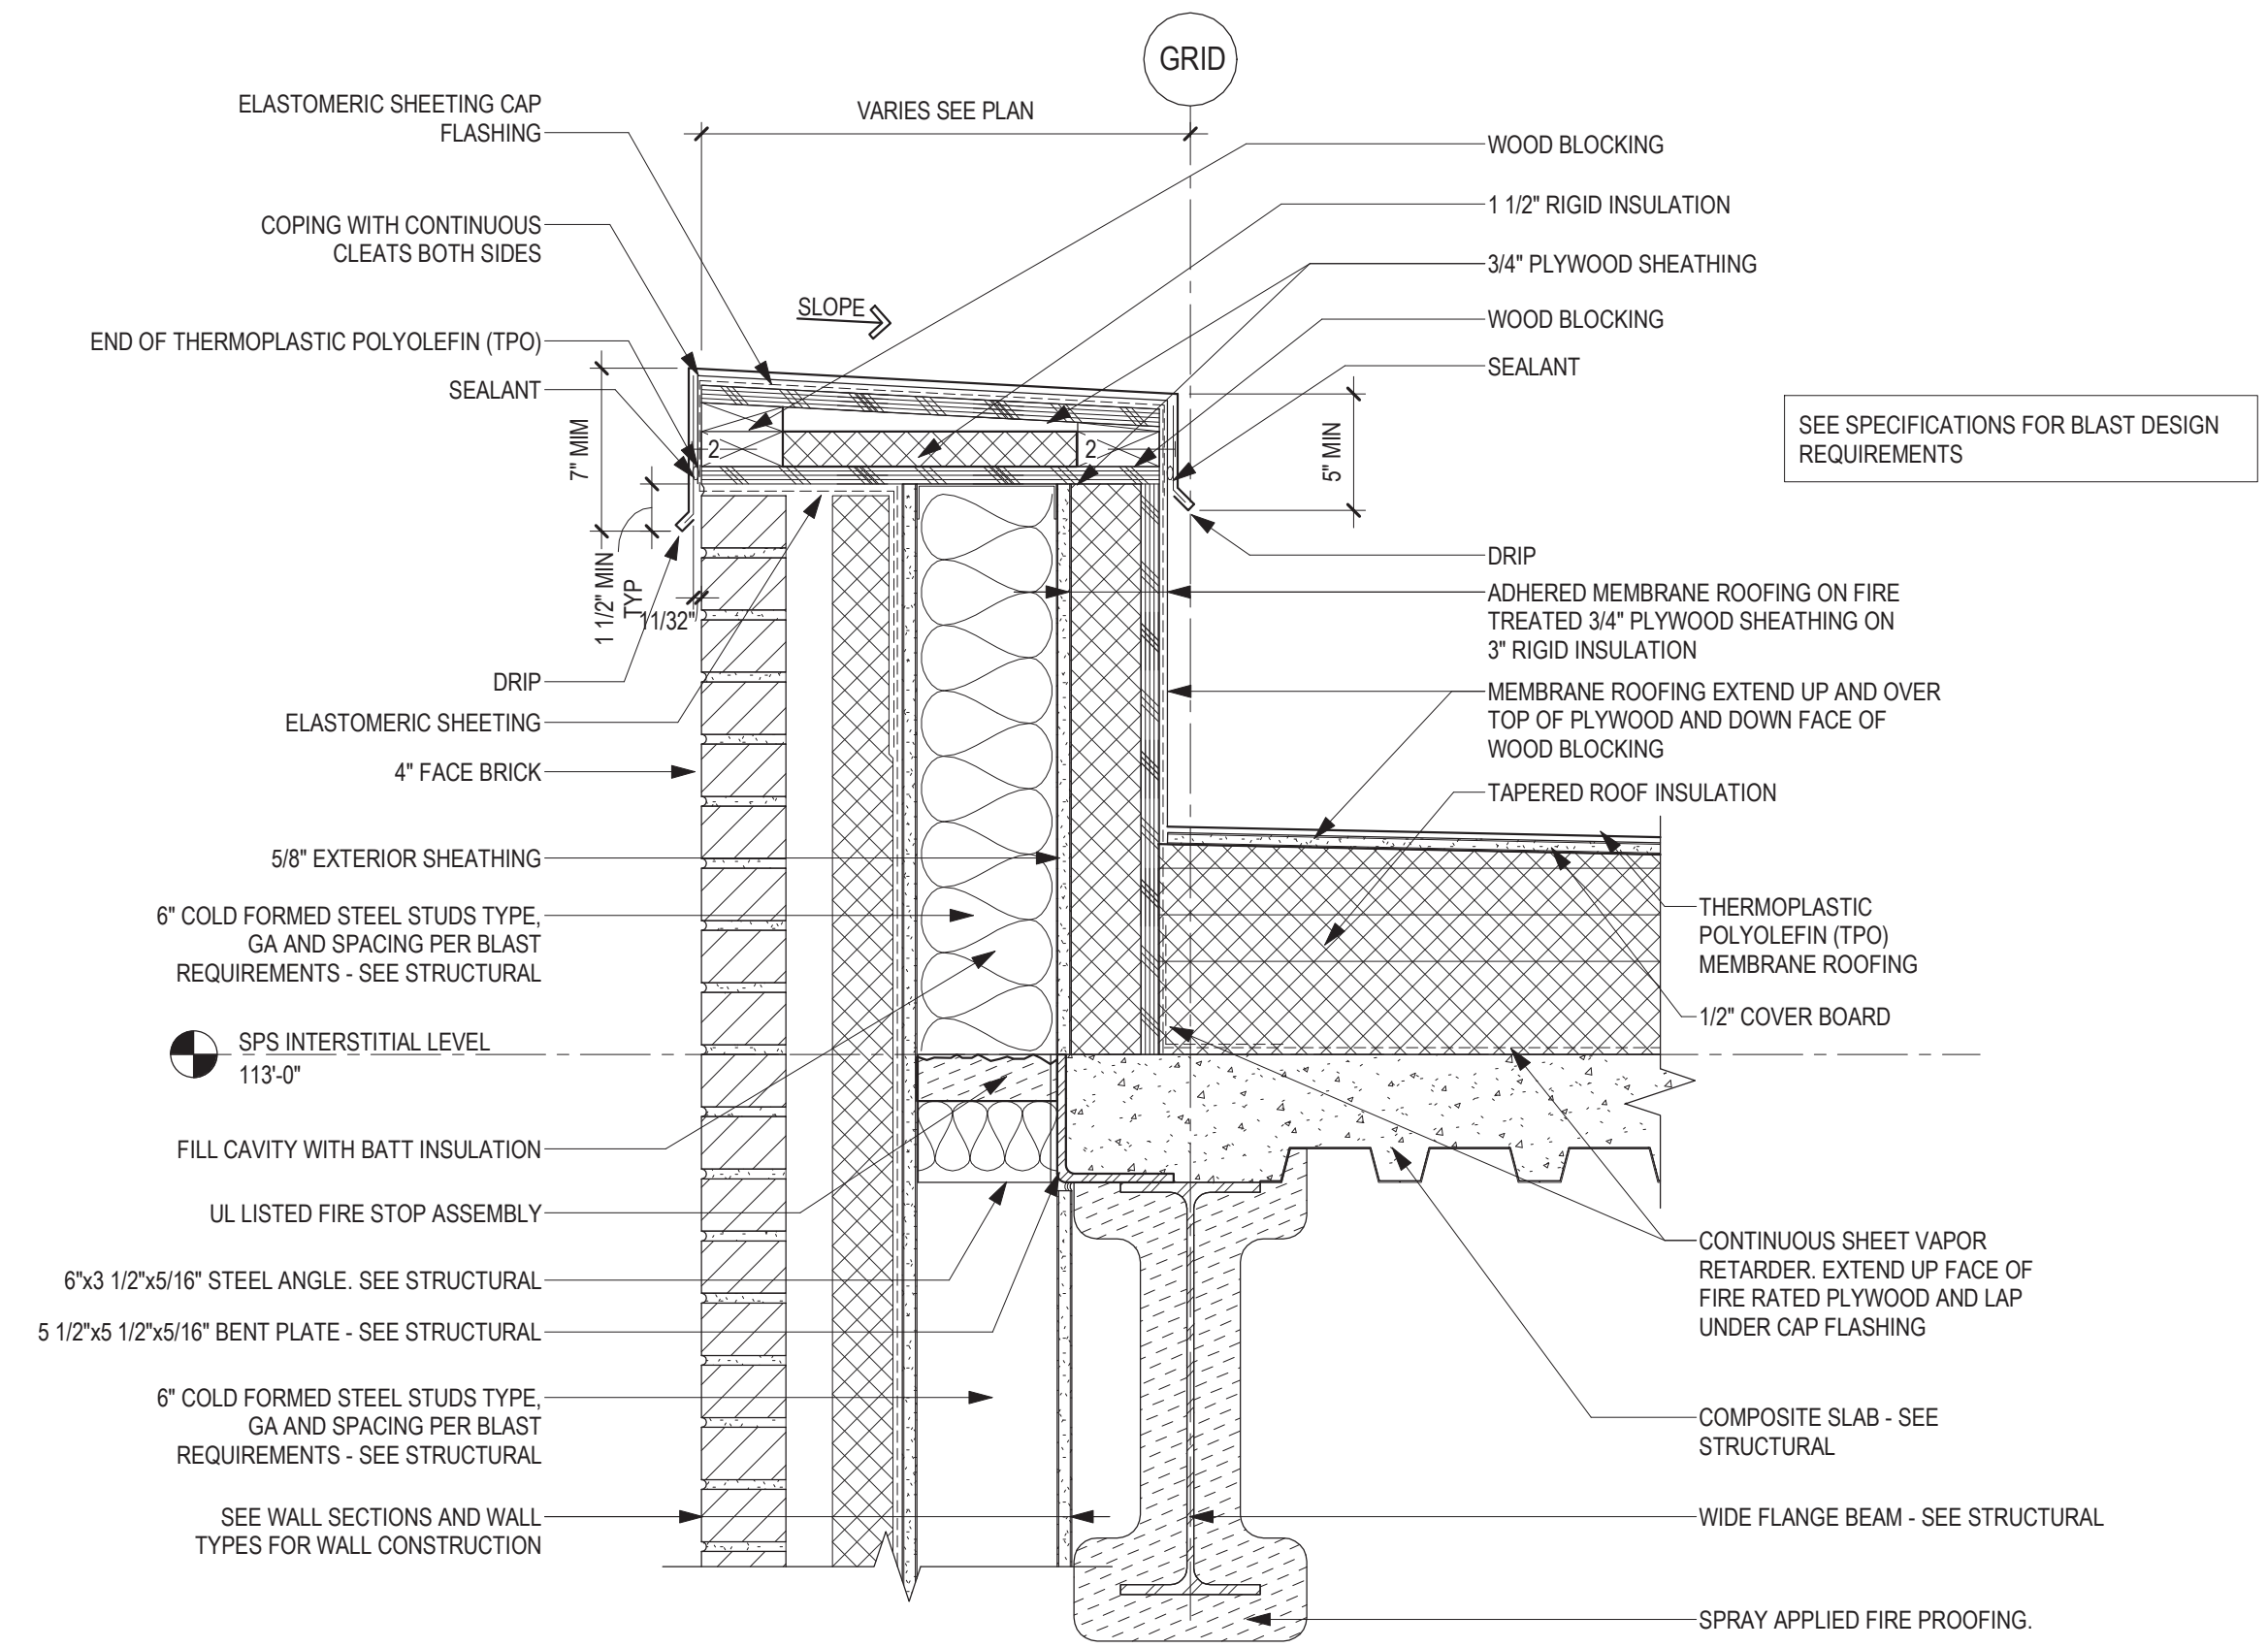


1 SECTION DETAIL - PARAPET AT BRICK WALL WITH METALS STUD BACK UP
1 1/2" = 1'-0"

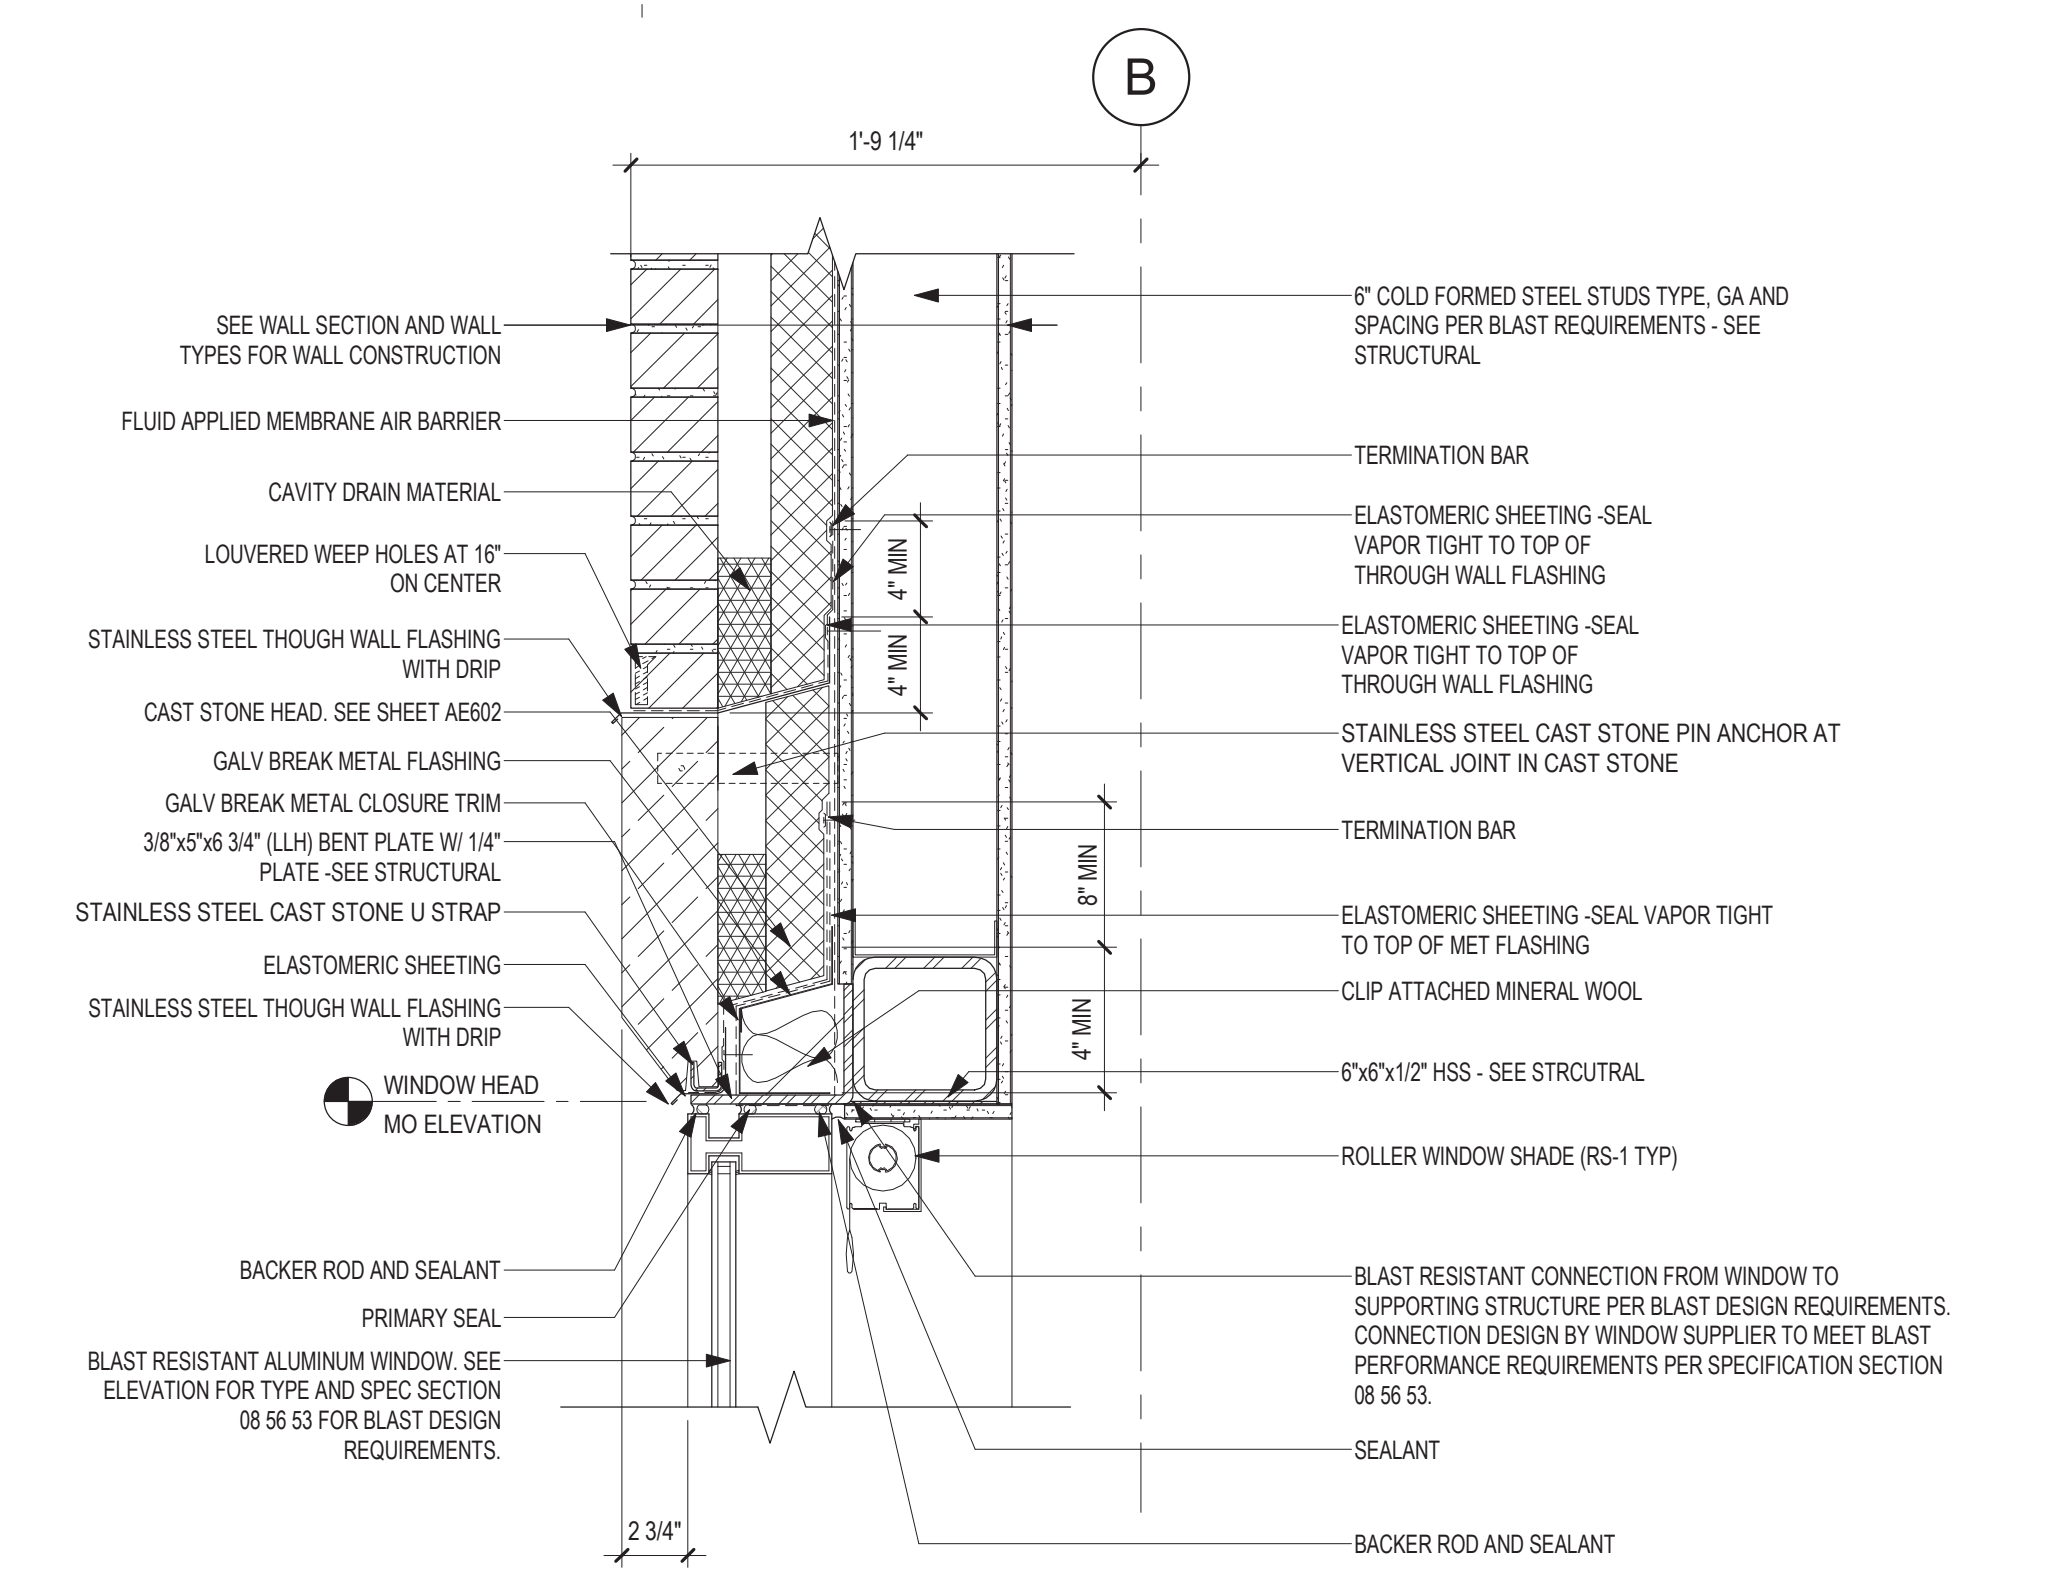


3 SECTION DETAIL - WINDOW HEAD @ BRICK (TYP)
1 1/2" = 1'-0"

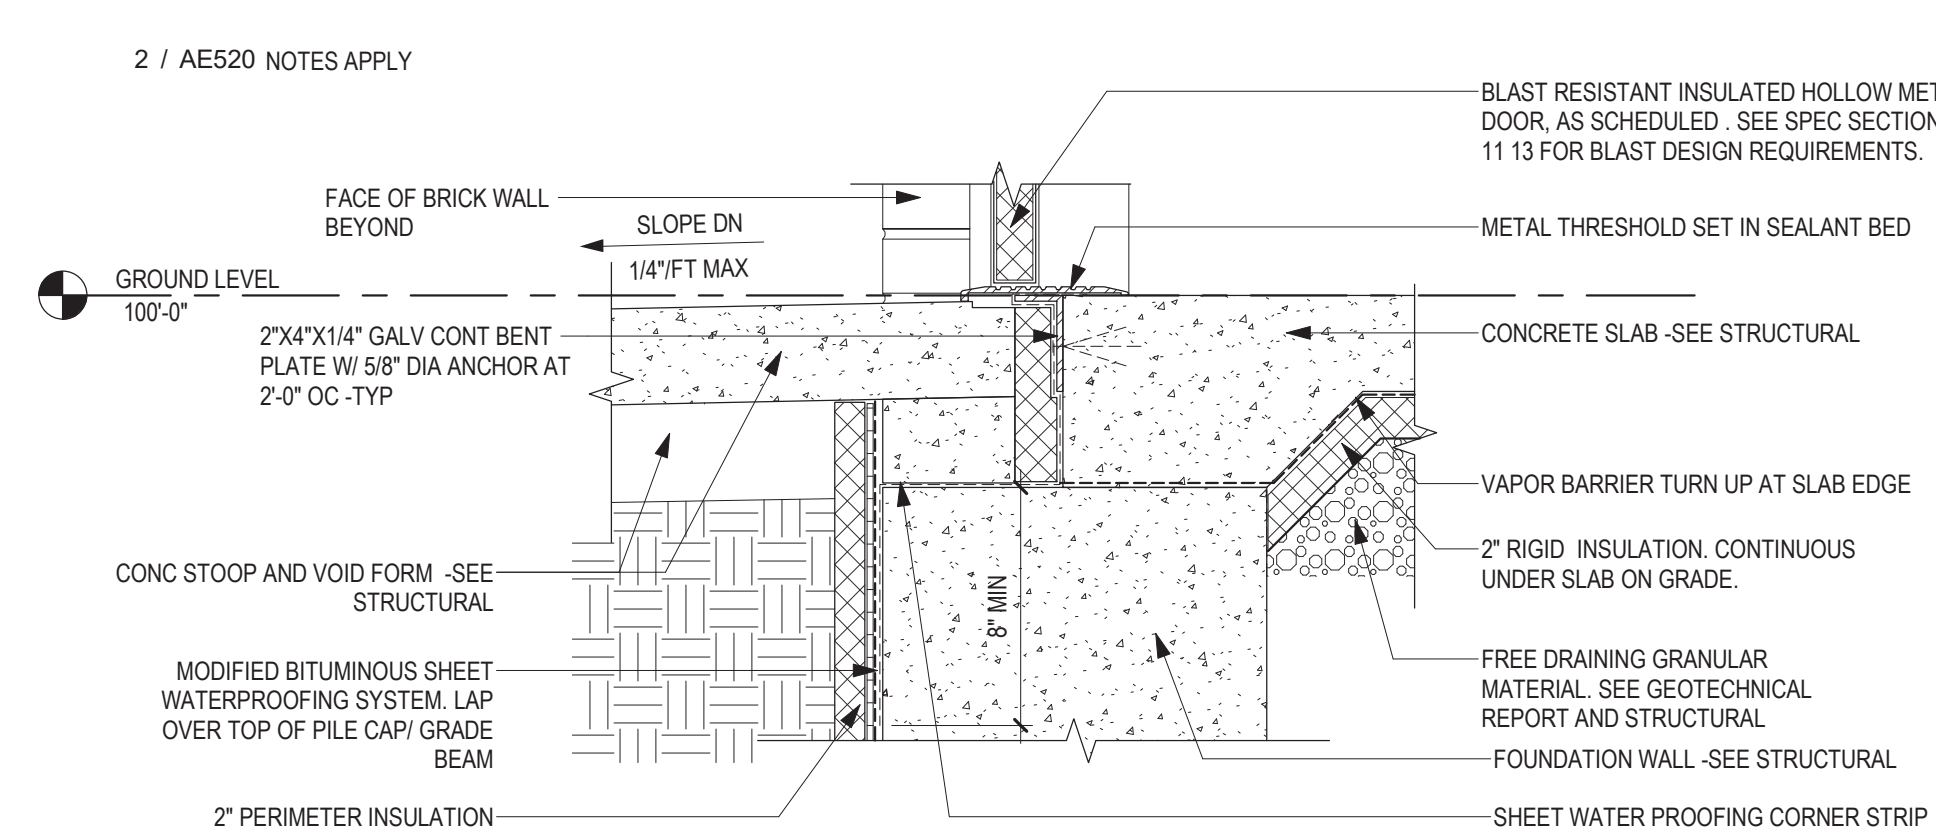


6 SECTION DETAIL EXTERIOR - DOOR SILL
1 1/2" = 1'-0"

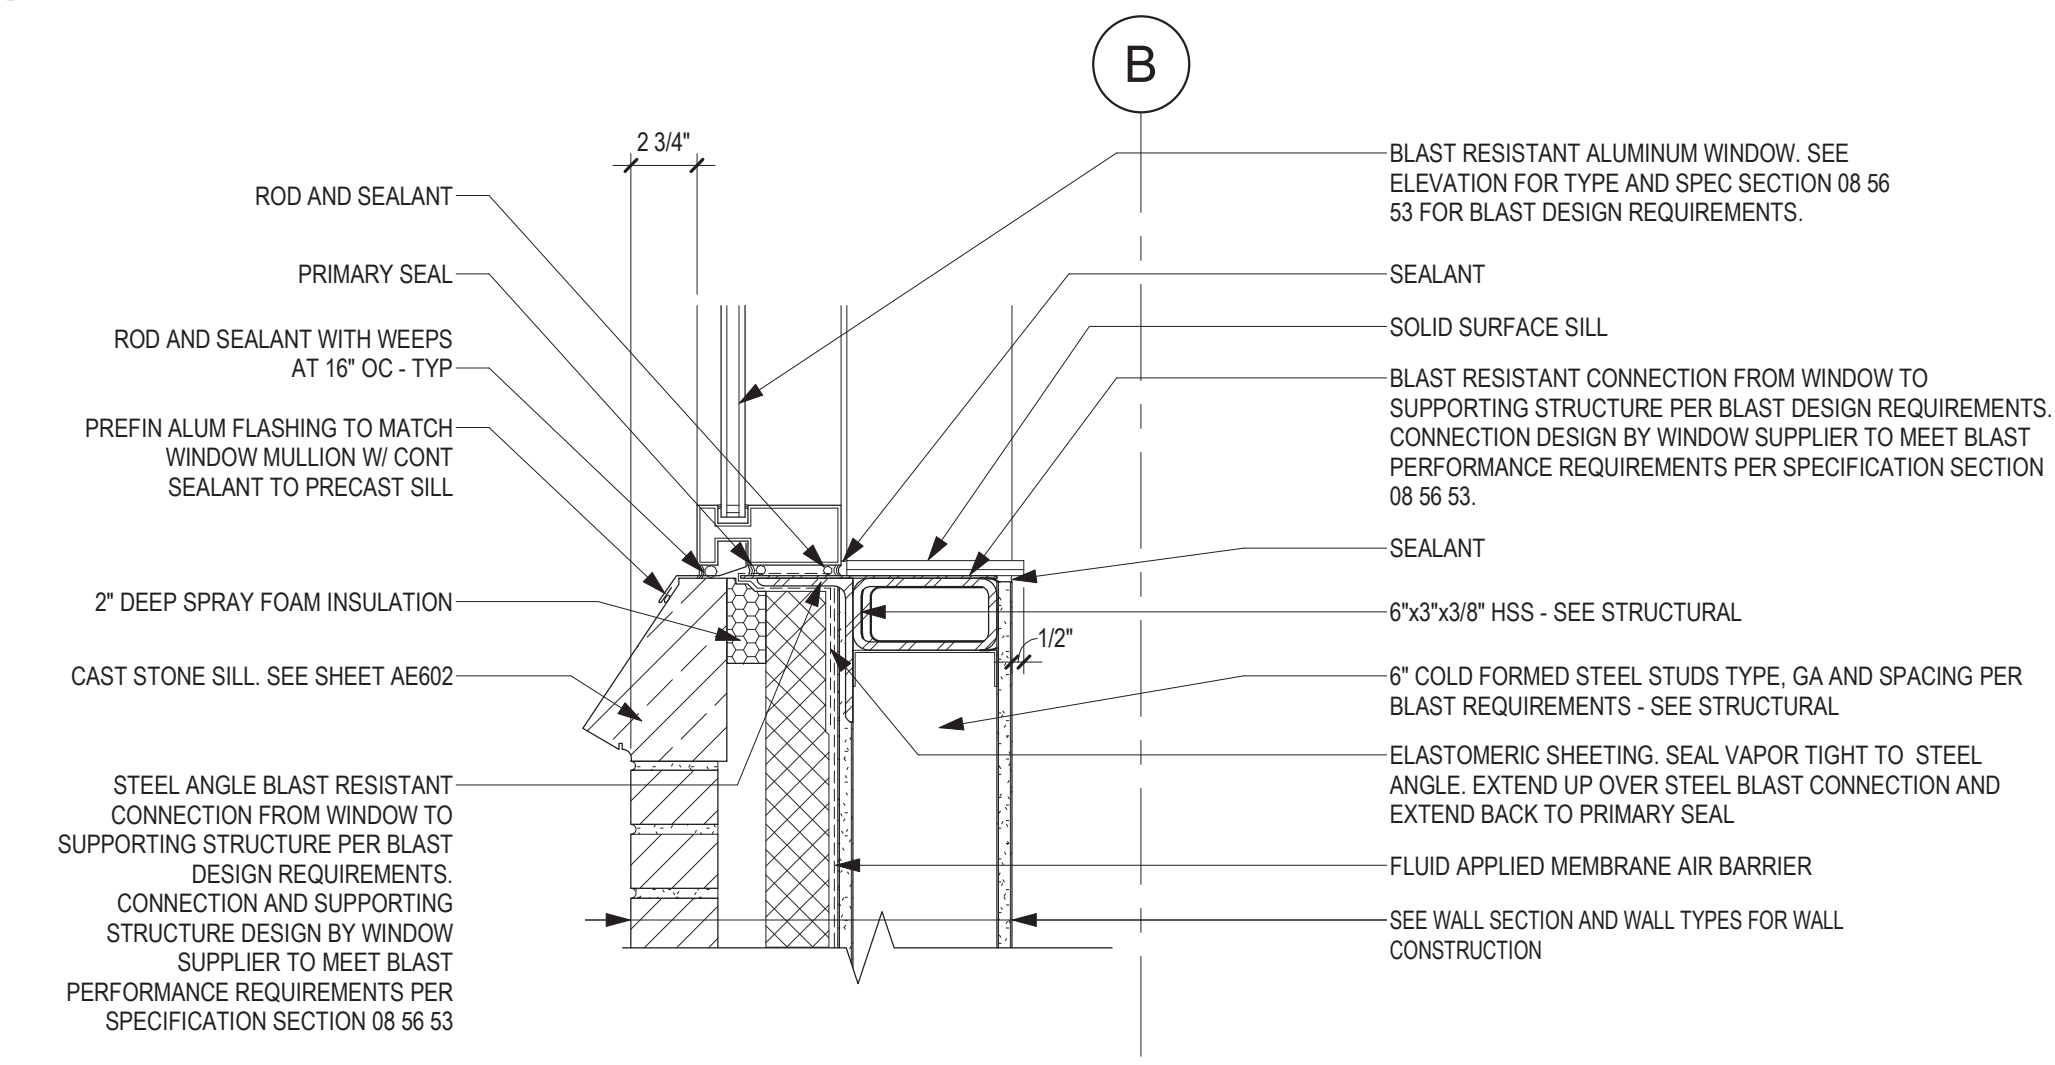


5 SECTION DETAIL - WINDOW SILL @ BRICK (TYP)
1 1/2" = 1'-0"

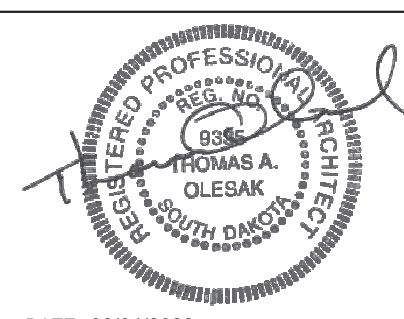
<table border="1"><thead><tr><th>Revisions:</th><th>Date:</th></tr></thead><tbody><tr><td> </td><td> </td></tr><tr><td> </td><td> </td></tr><tr><td> </td><td> </td></tr></tbody></table>	Revisions:	Date:							CONSULTANT 	ARCHITECT/ENGINEER OF RECORD  13605 1st Ave. N. #100 Plymouth, MN 55441 P 763.412.4000 F 763.412.4090 ae-mm.com Anderson Engineering of Minnesota, LLC Proj # 16584	STAMP  DATE: 08/04/2022 License # 9335	Office of Construction and Facilities Management  U.S. Department of Veterans Affairs	Drawing Title EXTERIOR SECTION DETAILS Approved:	Phase BID DOCUMENTS FULLY SPRINKLERED	Project Title CONSTRUCT NEW SPS Location Sioux Falls, SD. <table border="1"><tr><td>Issue Date 08/04/2022</td><td>Checked Checker</td><td>Drawn Author</td></tr></table>	Issue Date 08/04/2022	Checked Checker	Drawn Author	<table border="1"><tr><td>Project Number 438-460</td></tr><tr><td>Building Number 5</td></tr><tr><td>Drawing Number AE520</td></tr></table>	Project Number 438-460	Building Number 5	Drawing Number AE520
	Revisions:	Date:																				
Issue Date 08/04/2022	Checked Checker	Drawn Author																				
Project Number 438-460																						
Building Number 5																						
Drawing Number AE520																						

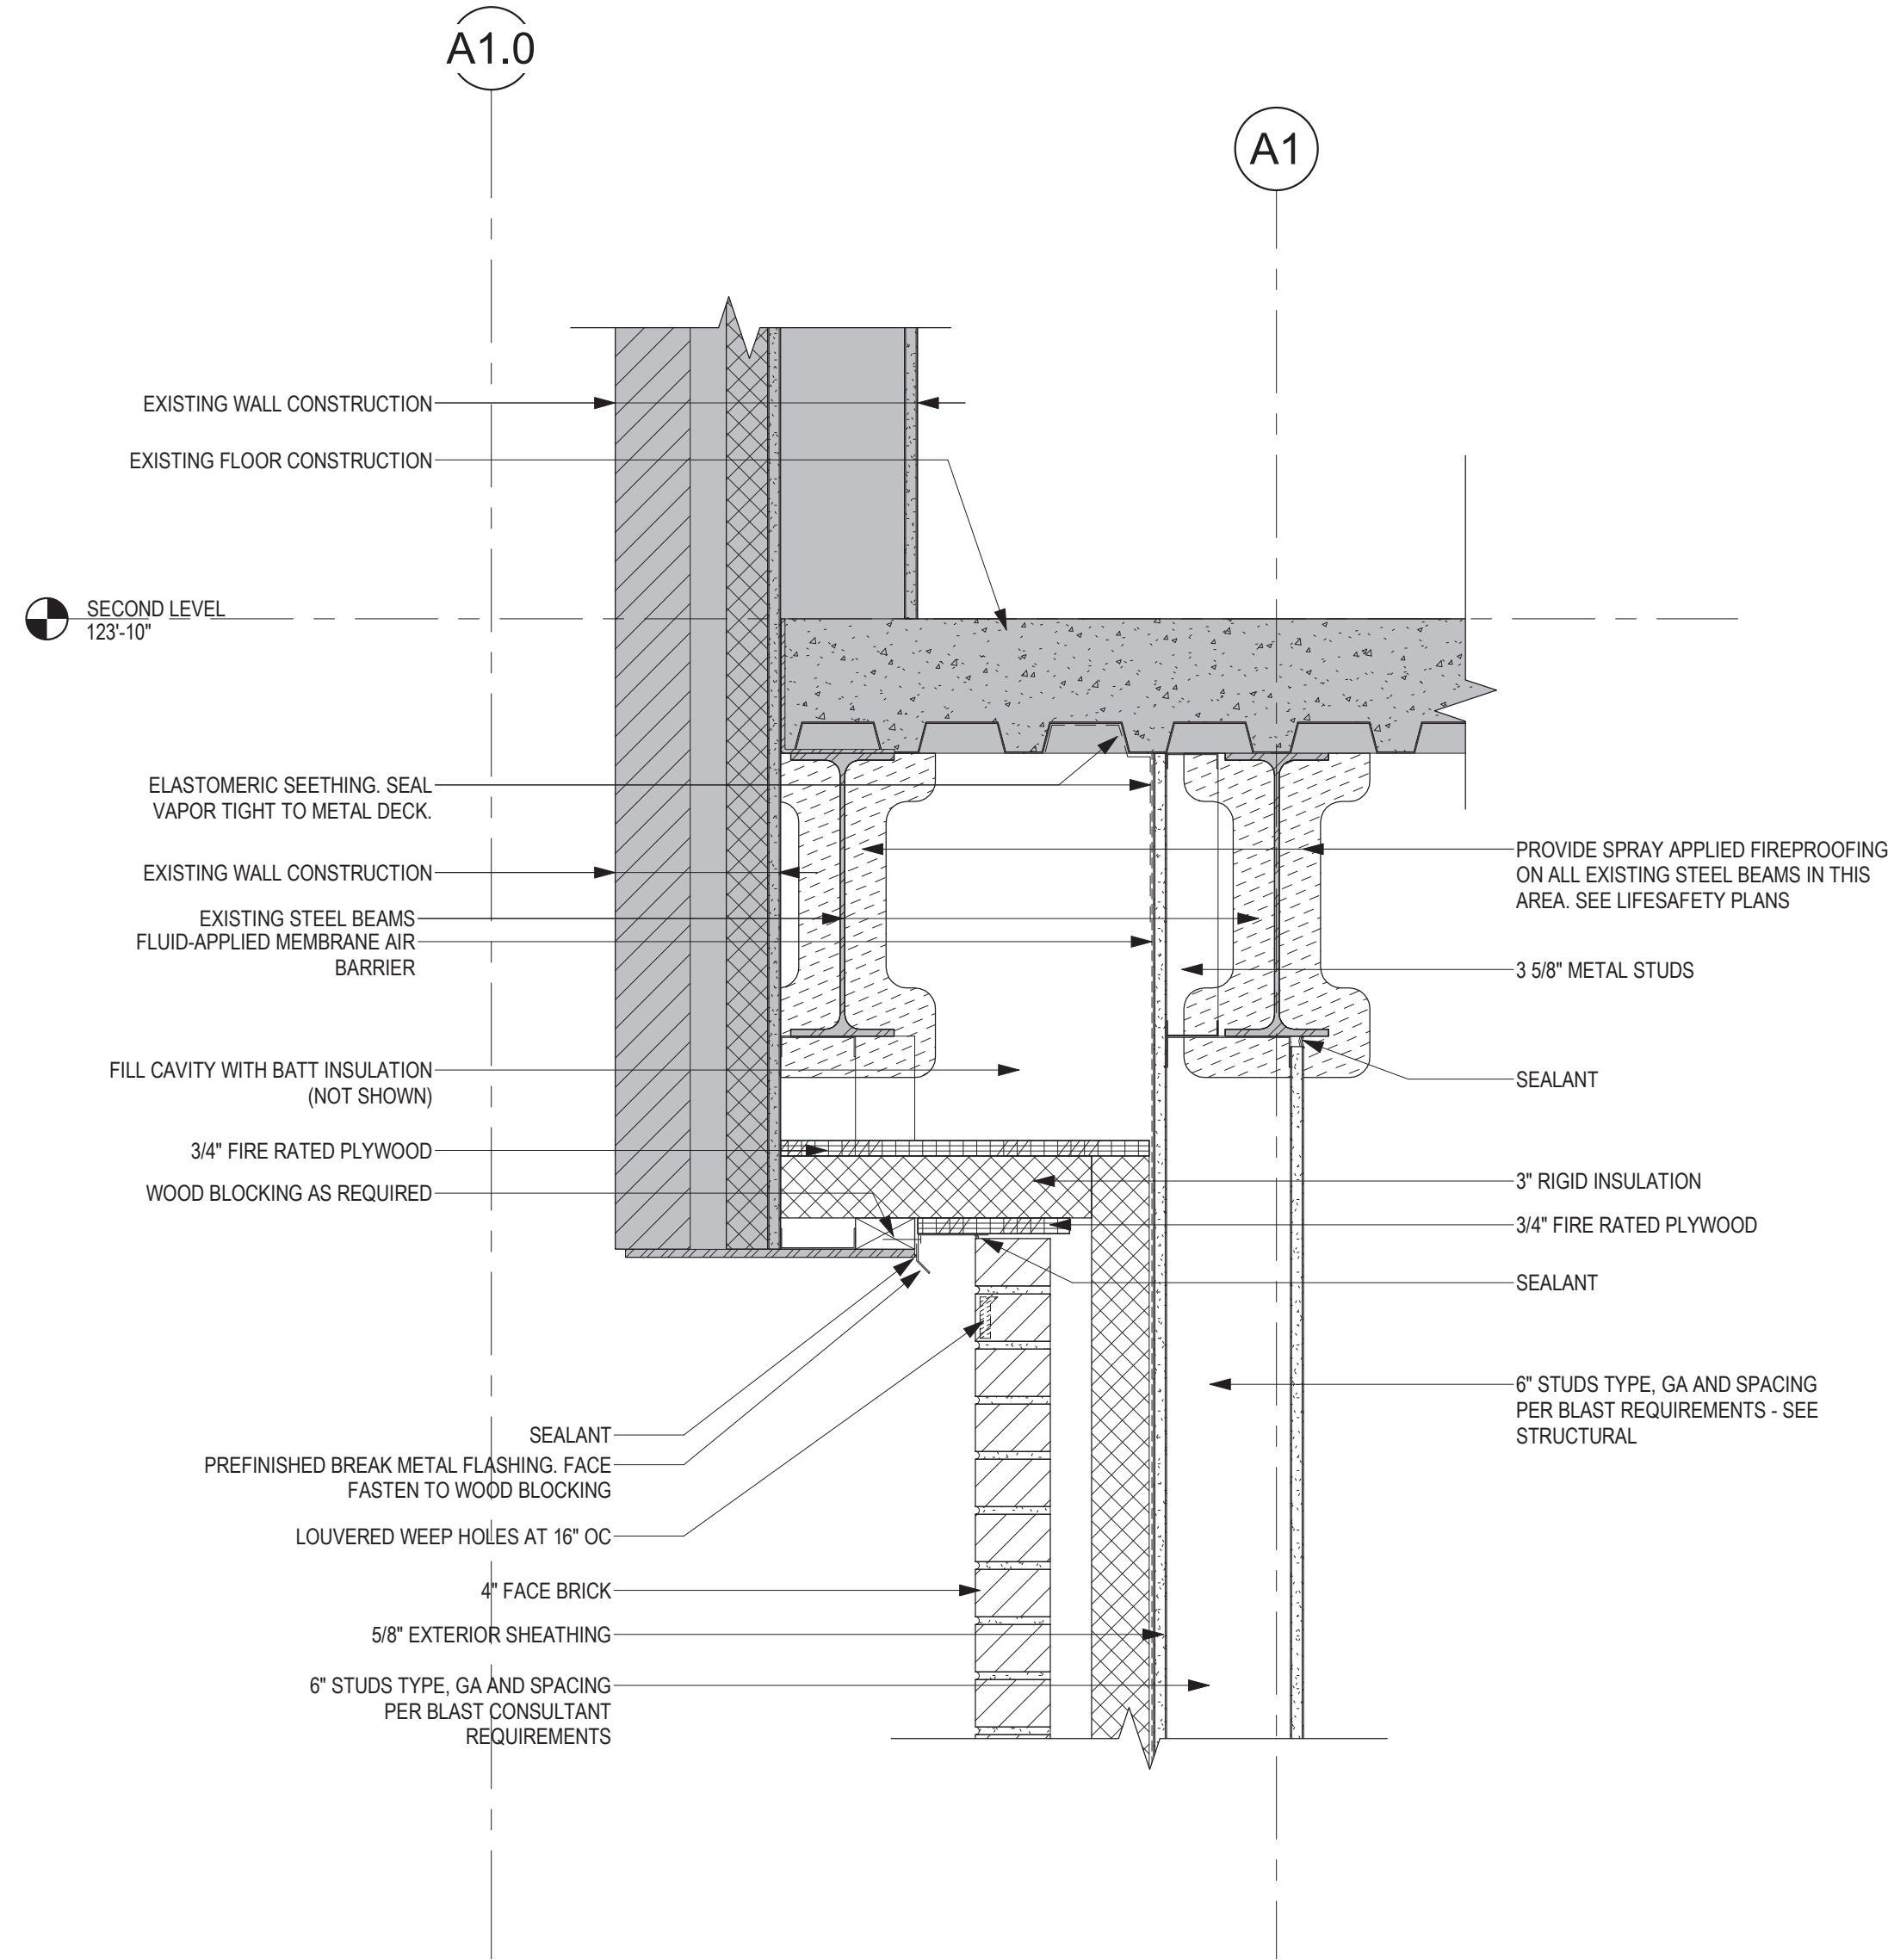


3 SECTION DETAIL - SOFFIT AT EXISTING ADDITION
1 1/2" = 1'-0"

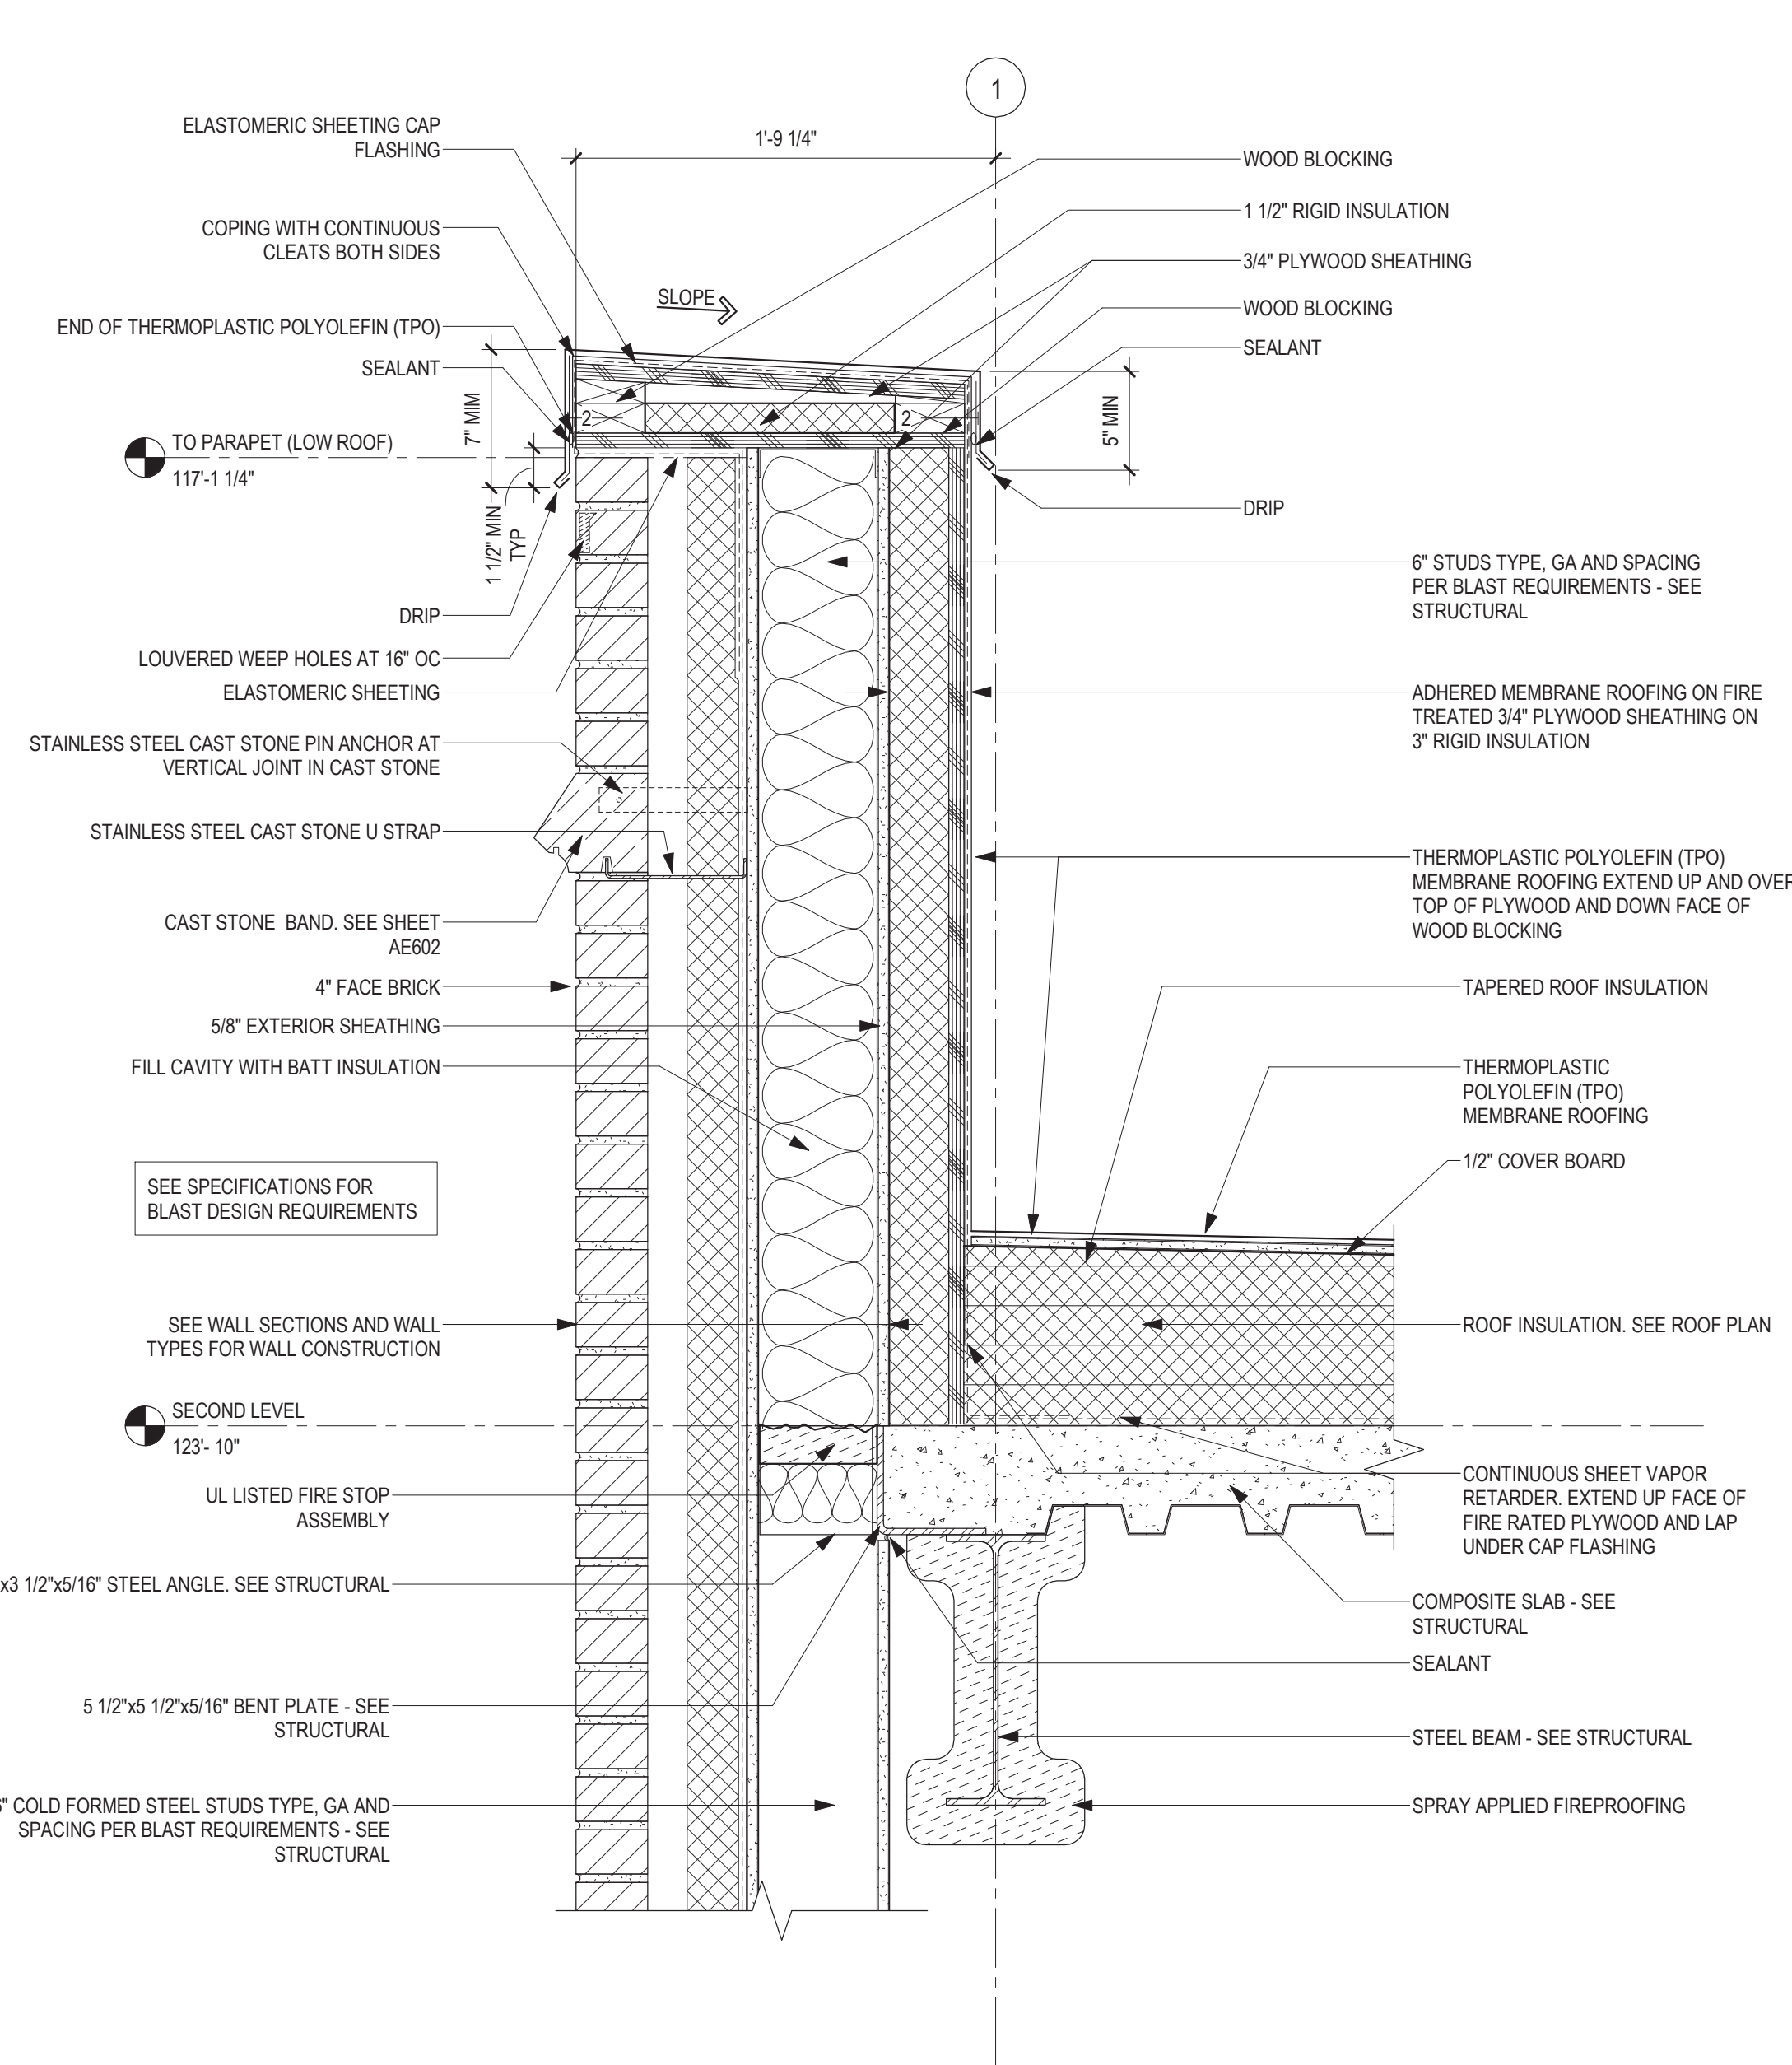


2 SECTION DETAIL - PARAPET AT BRICK WALL WITH METALS STUD - LOW ROOF
1 1/2" = 1'-0"

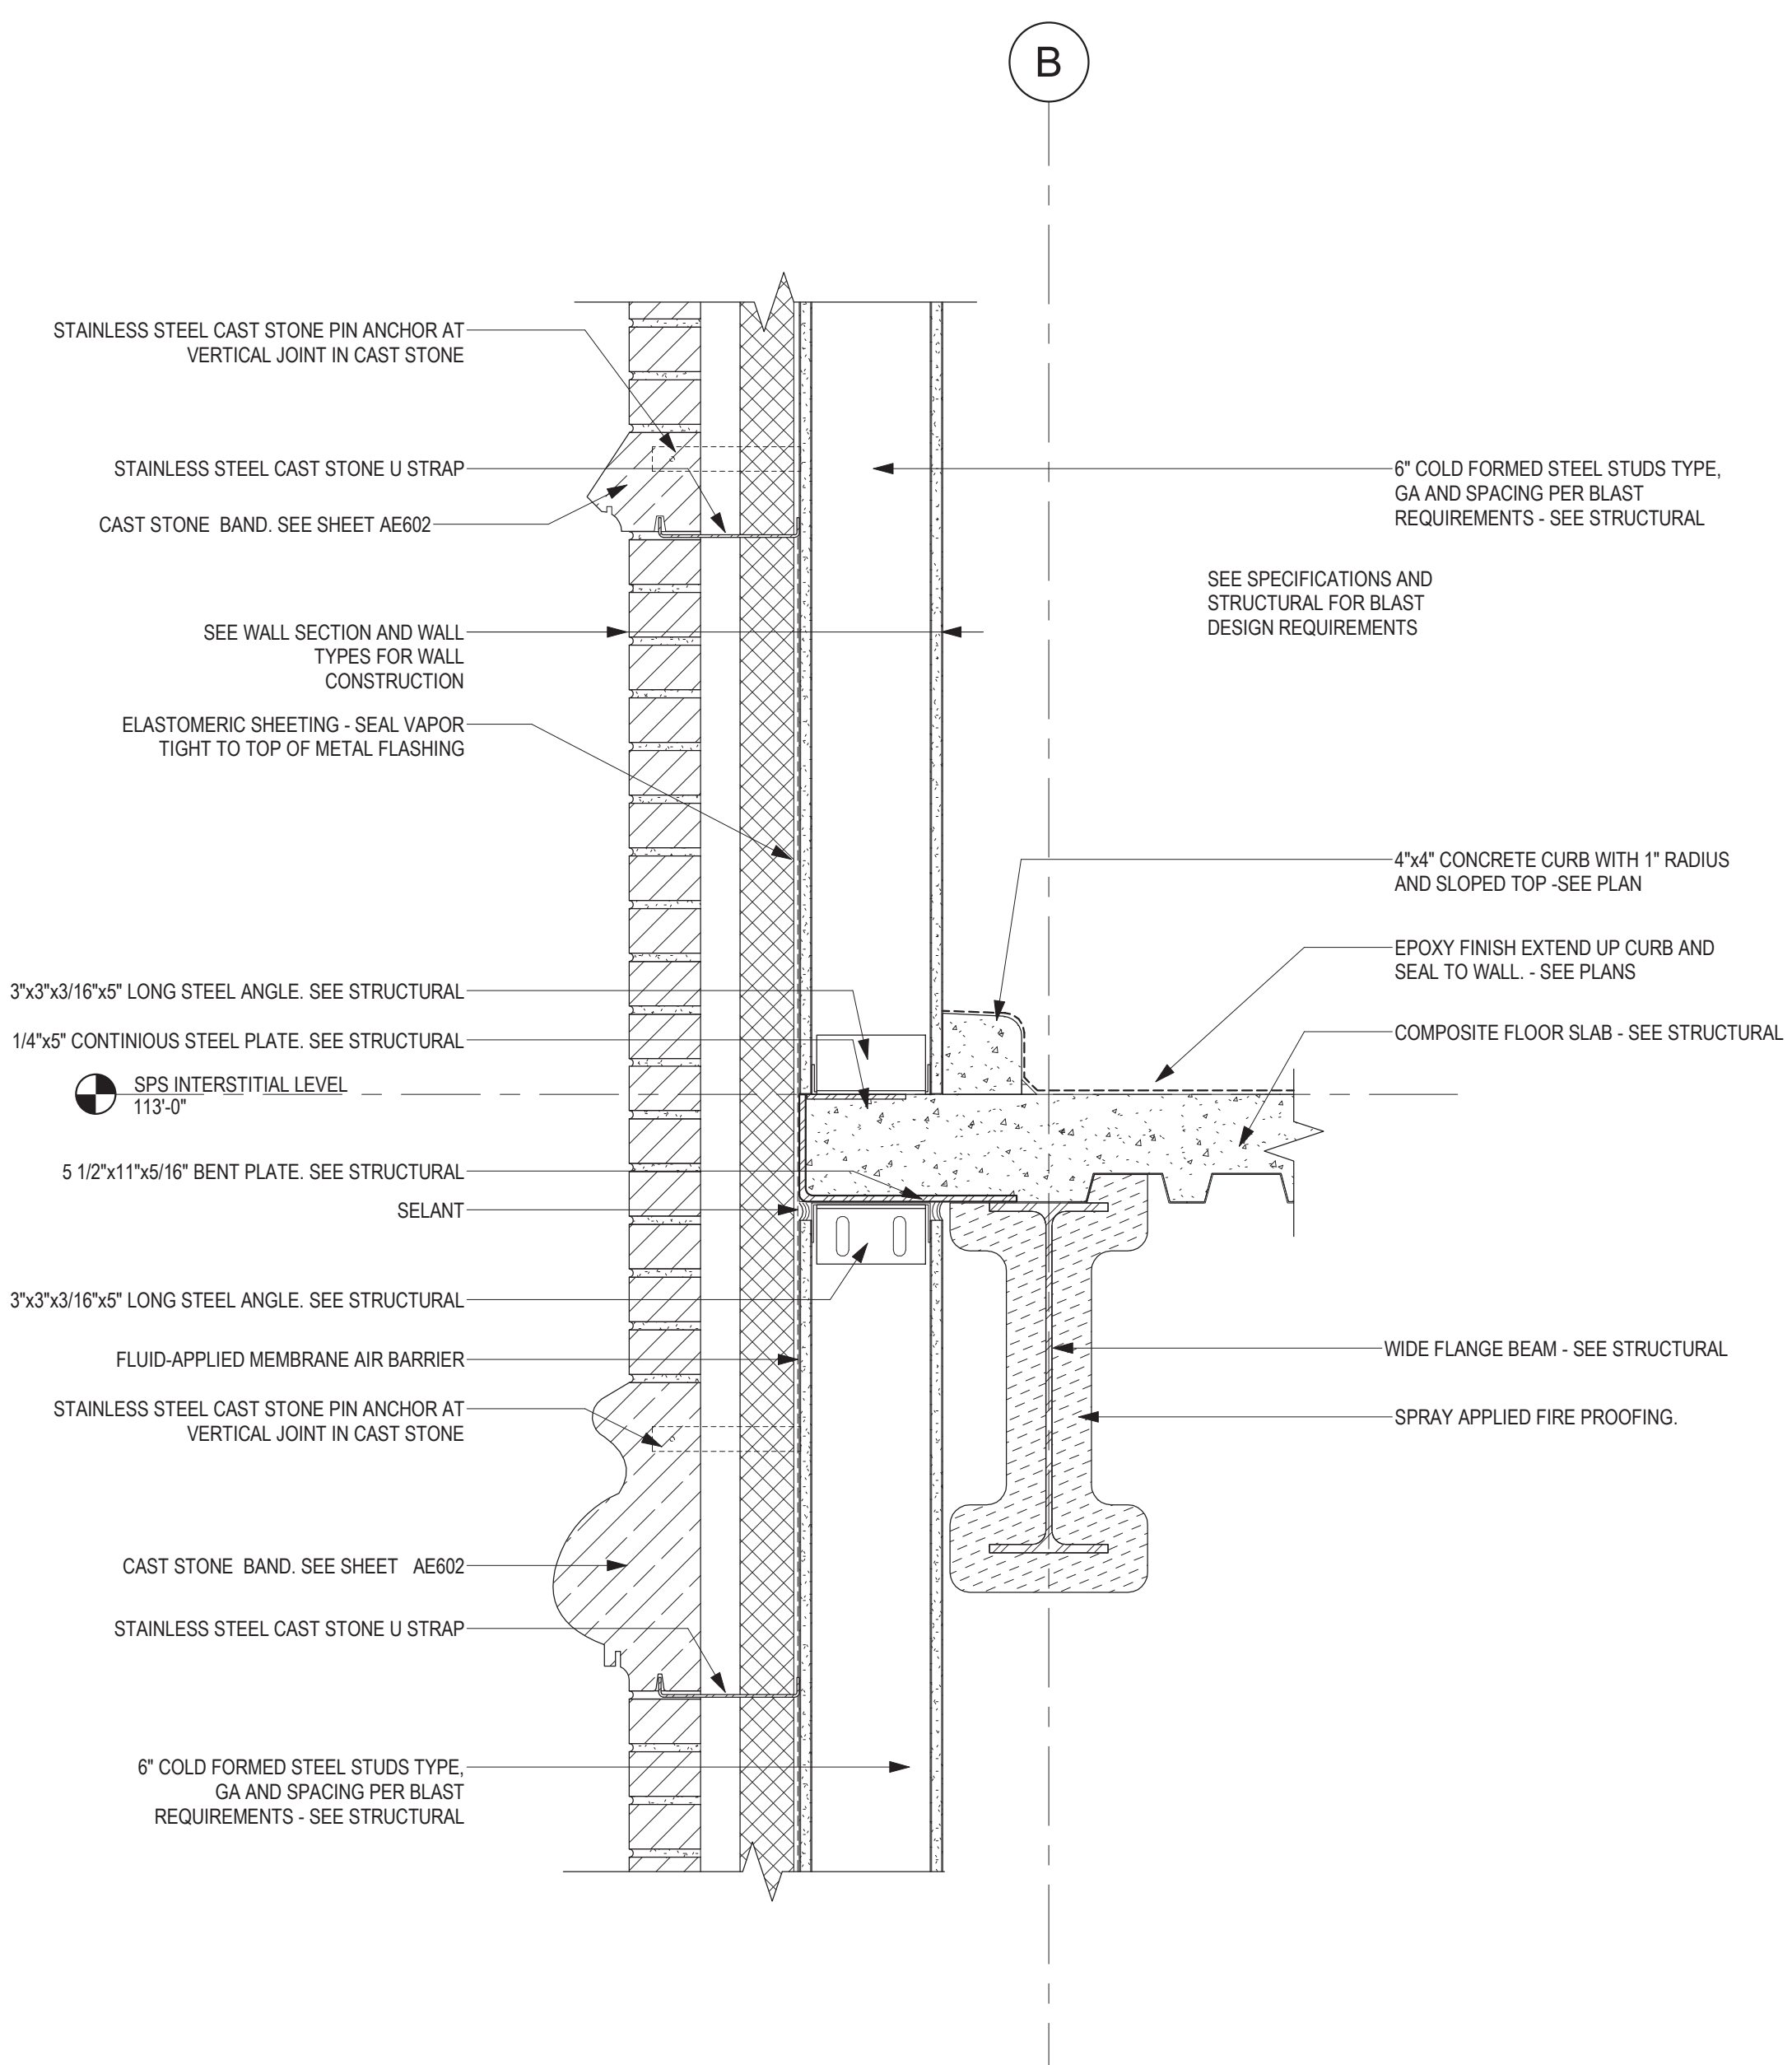


1 SECTION DETAIL - STONE BAND & SLAB EDGE
1 1/2" = 1'-0"

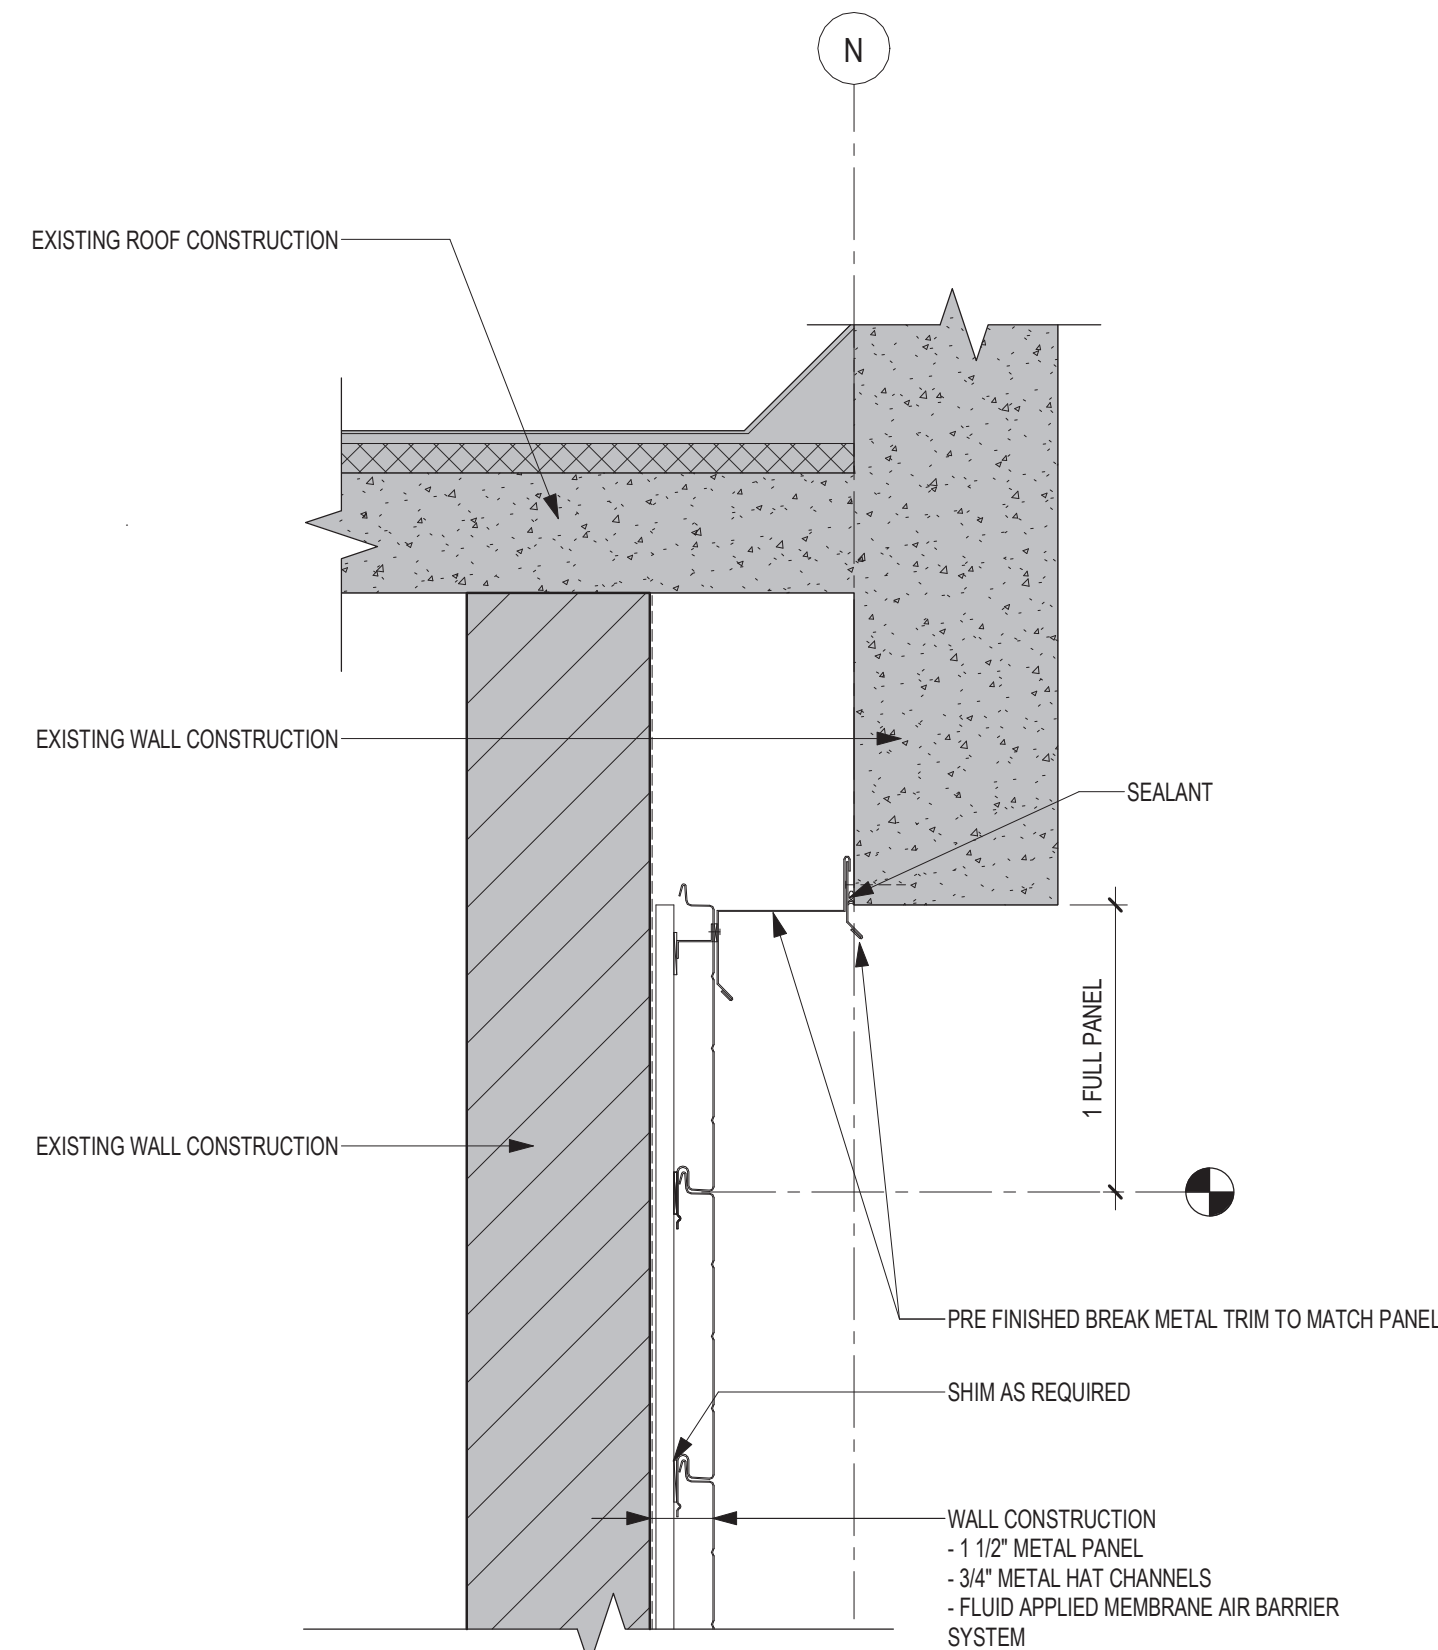

5 SECTION DETAIL - METAL PANEL AT PARAPET
1 1/2" = 1'-0"

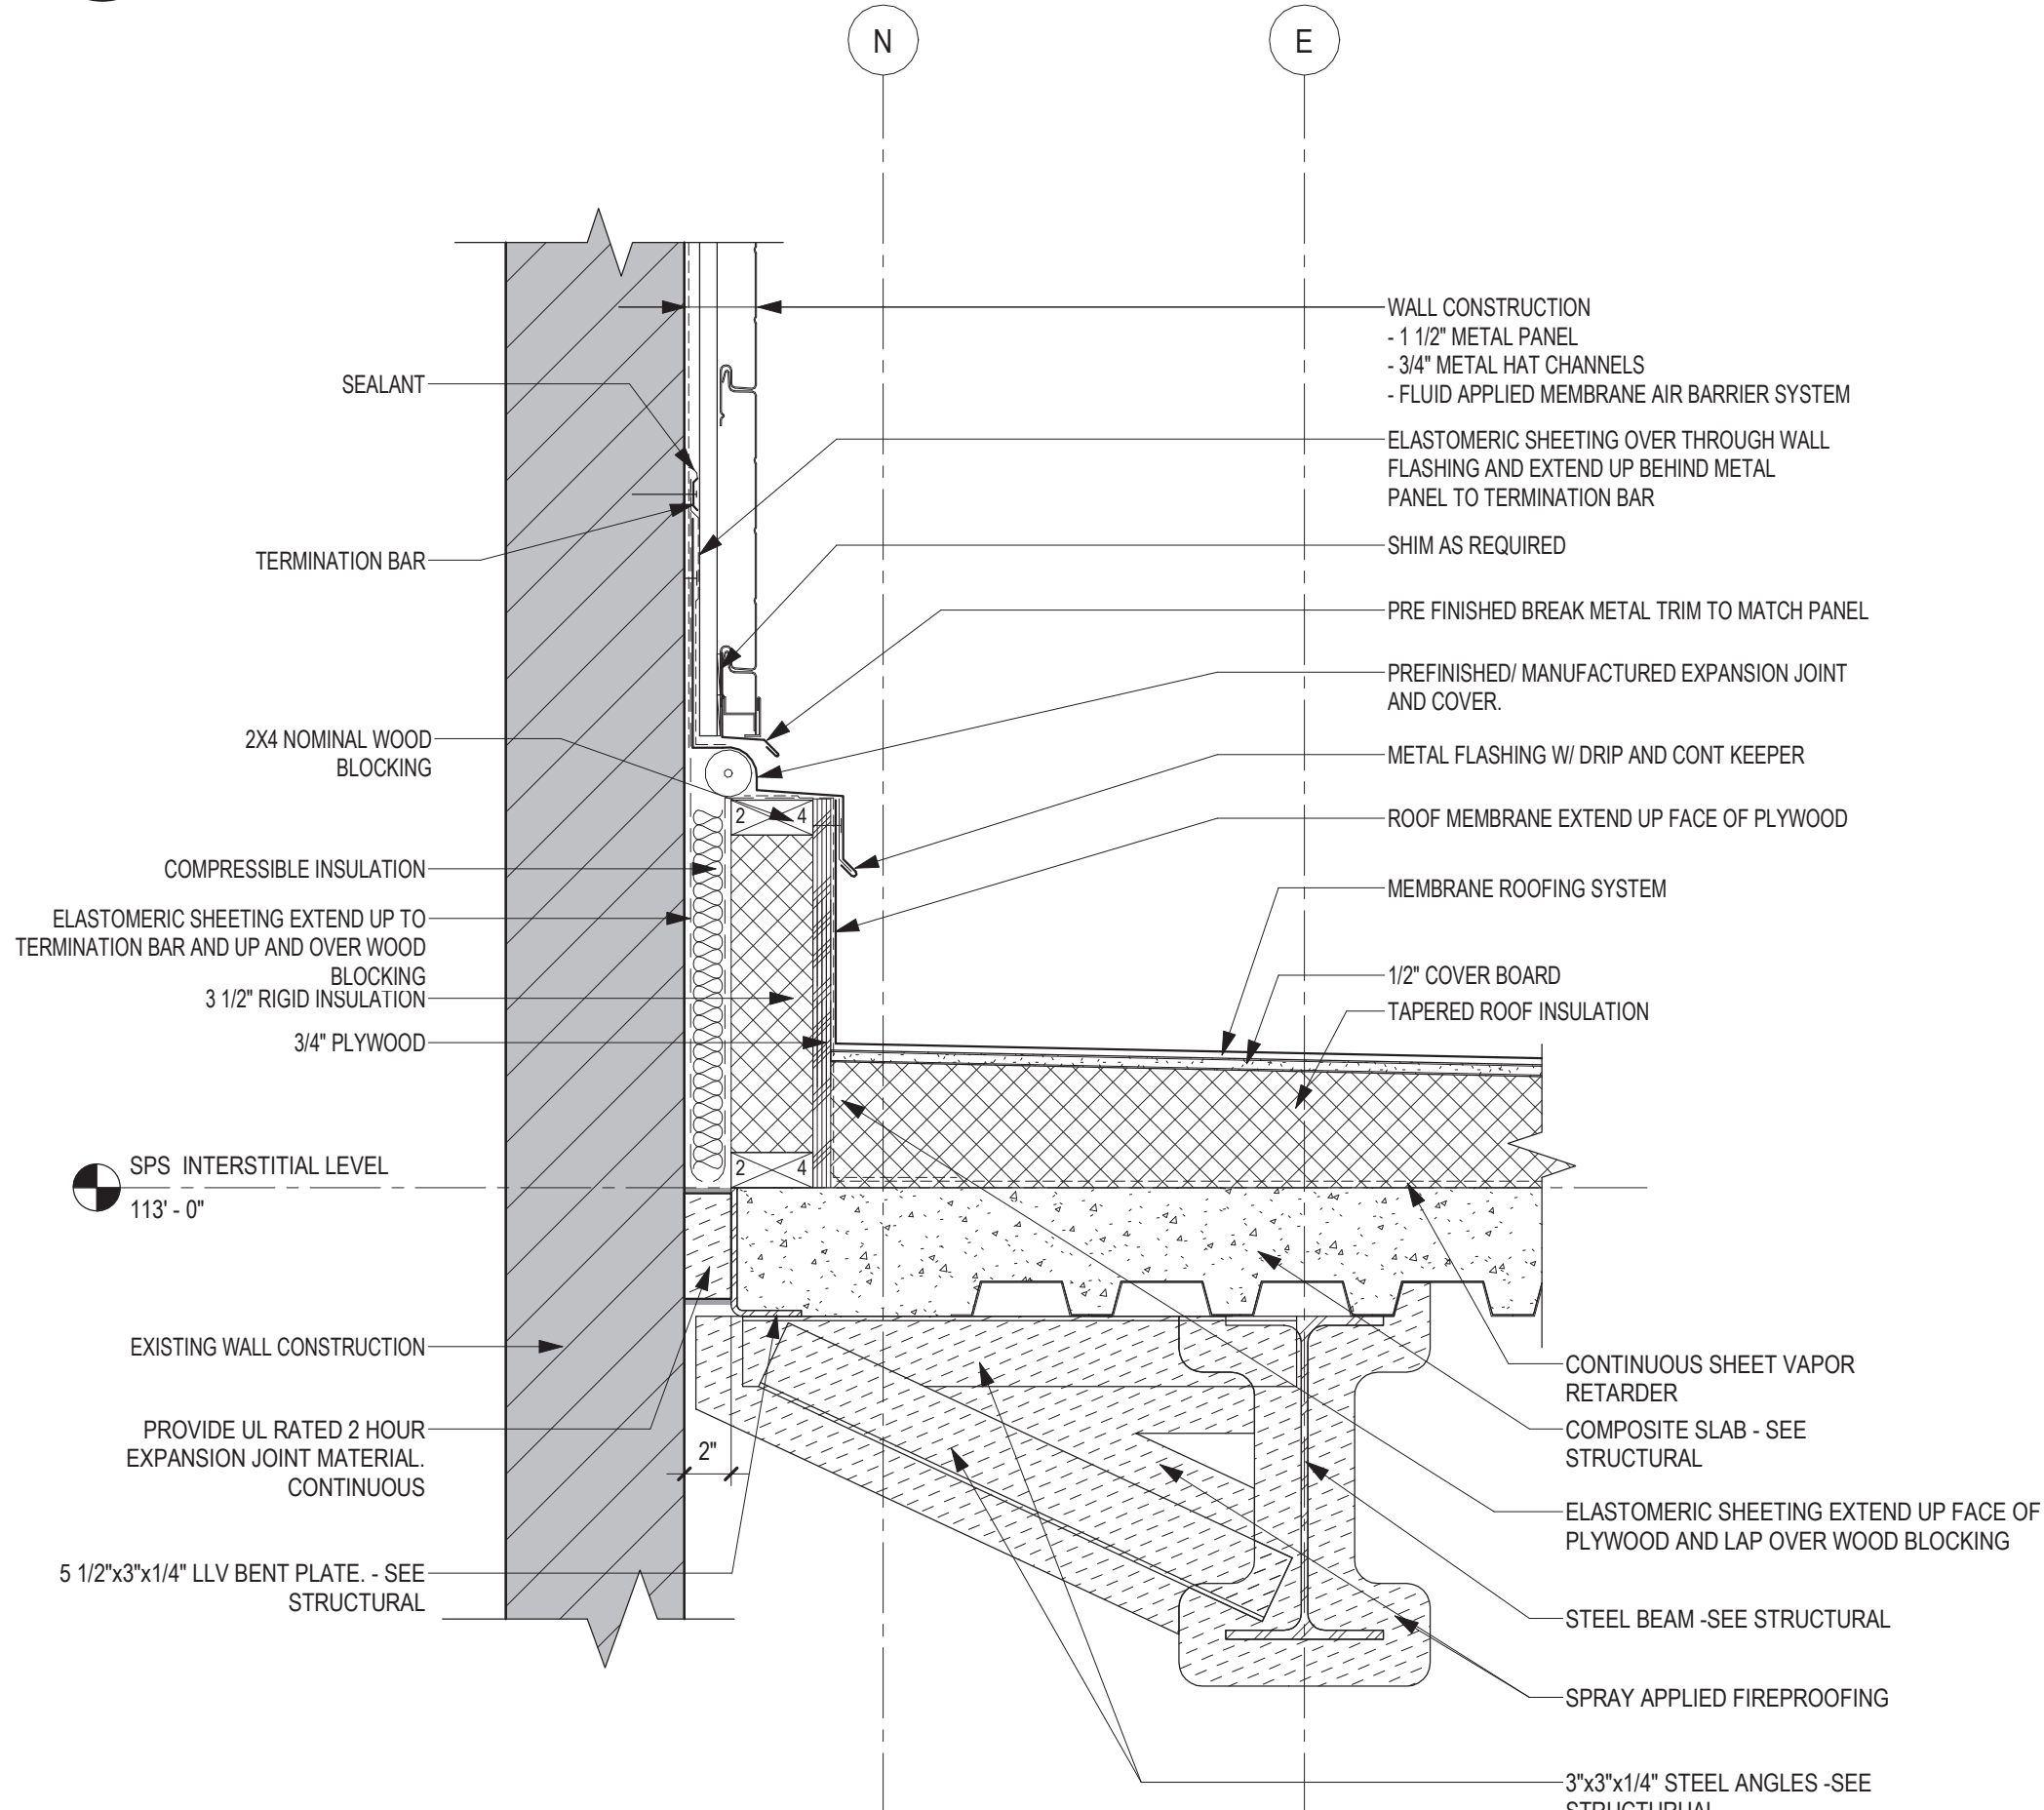

6 SECTION DETAIL - METAL PANEL BASE @ LOW ROOF GRID N
1 1/2" = 1'-0"

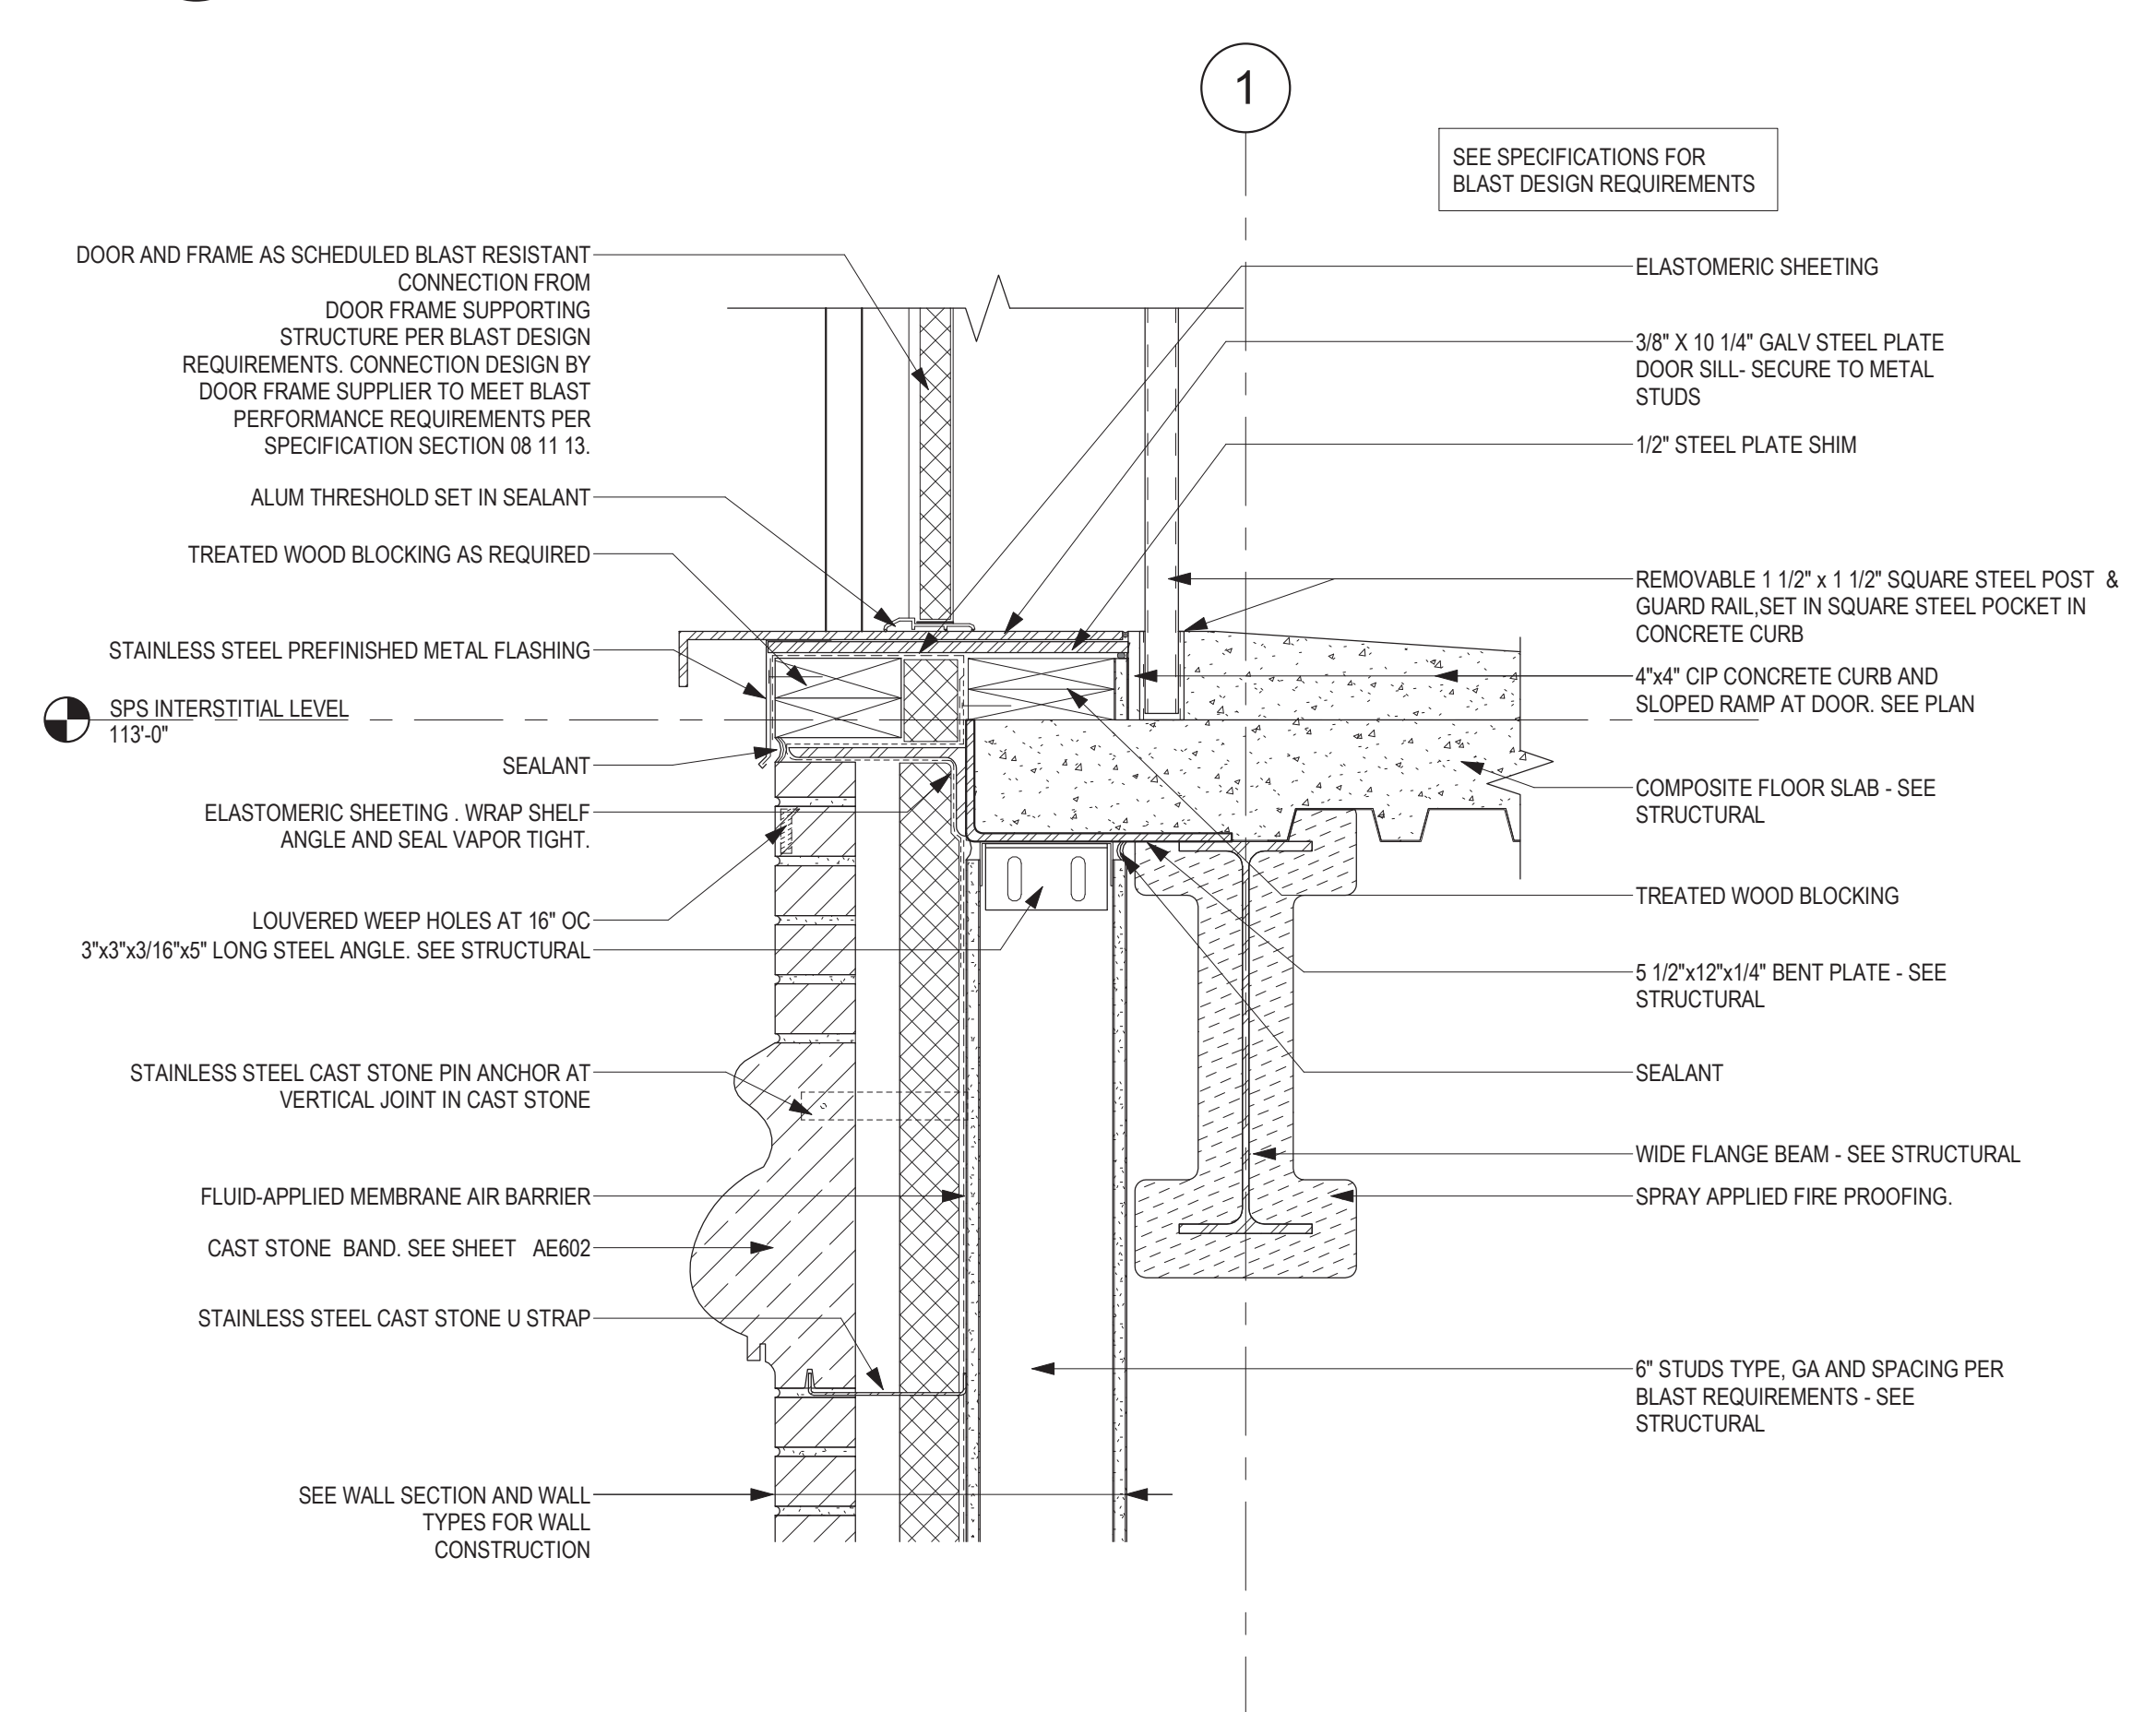

4 SECTION DETAIL - INTERSTITIAL DOOR SILL AND STONE BAND
1 1/2" = 1'-0"

Revisions:	Date:

CONSULTANT

ARCHITECT/ENGINEER OF RECORD

13605 1st Ave. N. #100 Plymouth, MN 55441
P 763.412.4000 | F 763.412.4090 | ae-mn.com
Anderson Engineering of Minnesota, LLC | Proj # 16584

Office of Construction and Facilities Management

U.S. Department of Veterans Affairs

Drawing Title

EXTERIOR SECTION DETAILS

Approved:

Phase

BID DOCUMENTS

FULLY SPRINKLERED

Project Title

CONSTRUCT NEW SPS

Location

Sioux Falls, SD.

Issue Date

08/04/2022

Checked

Checker

Drawn

Author

Project Number

438-460


Building Number

5


Drawing Number

AE521


C:\Users\Public\Documents\Revit Projects\16584-RCT_gbarani@ae-mn.com.rvt 7/7/2023 1:28:09 PM

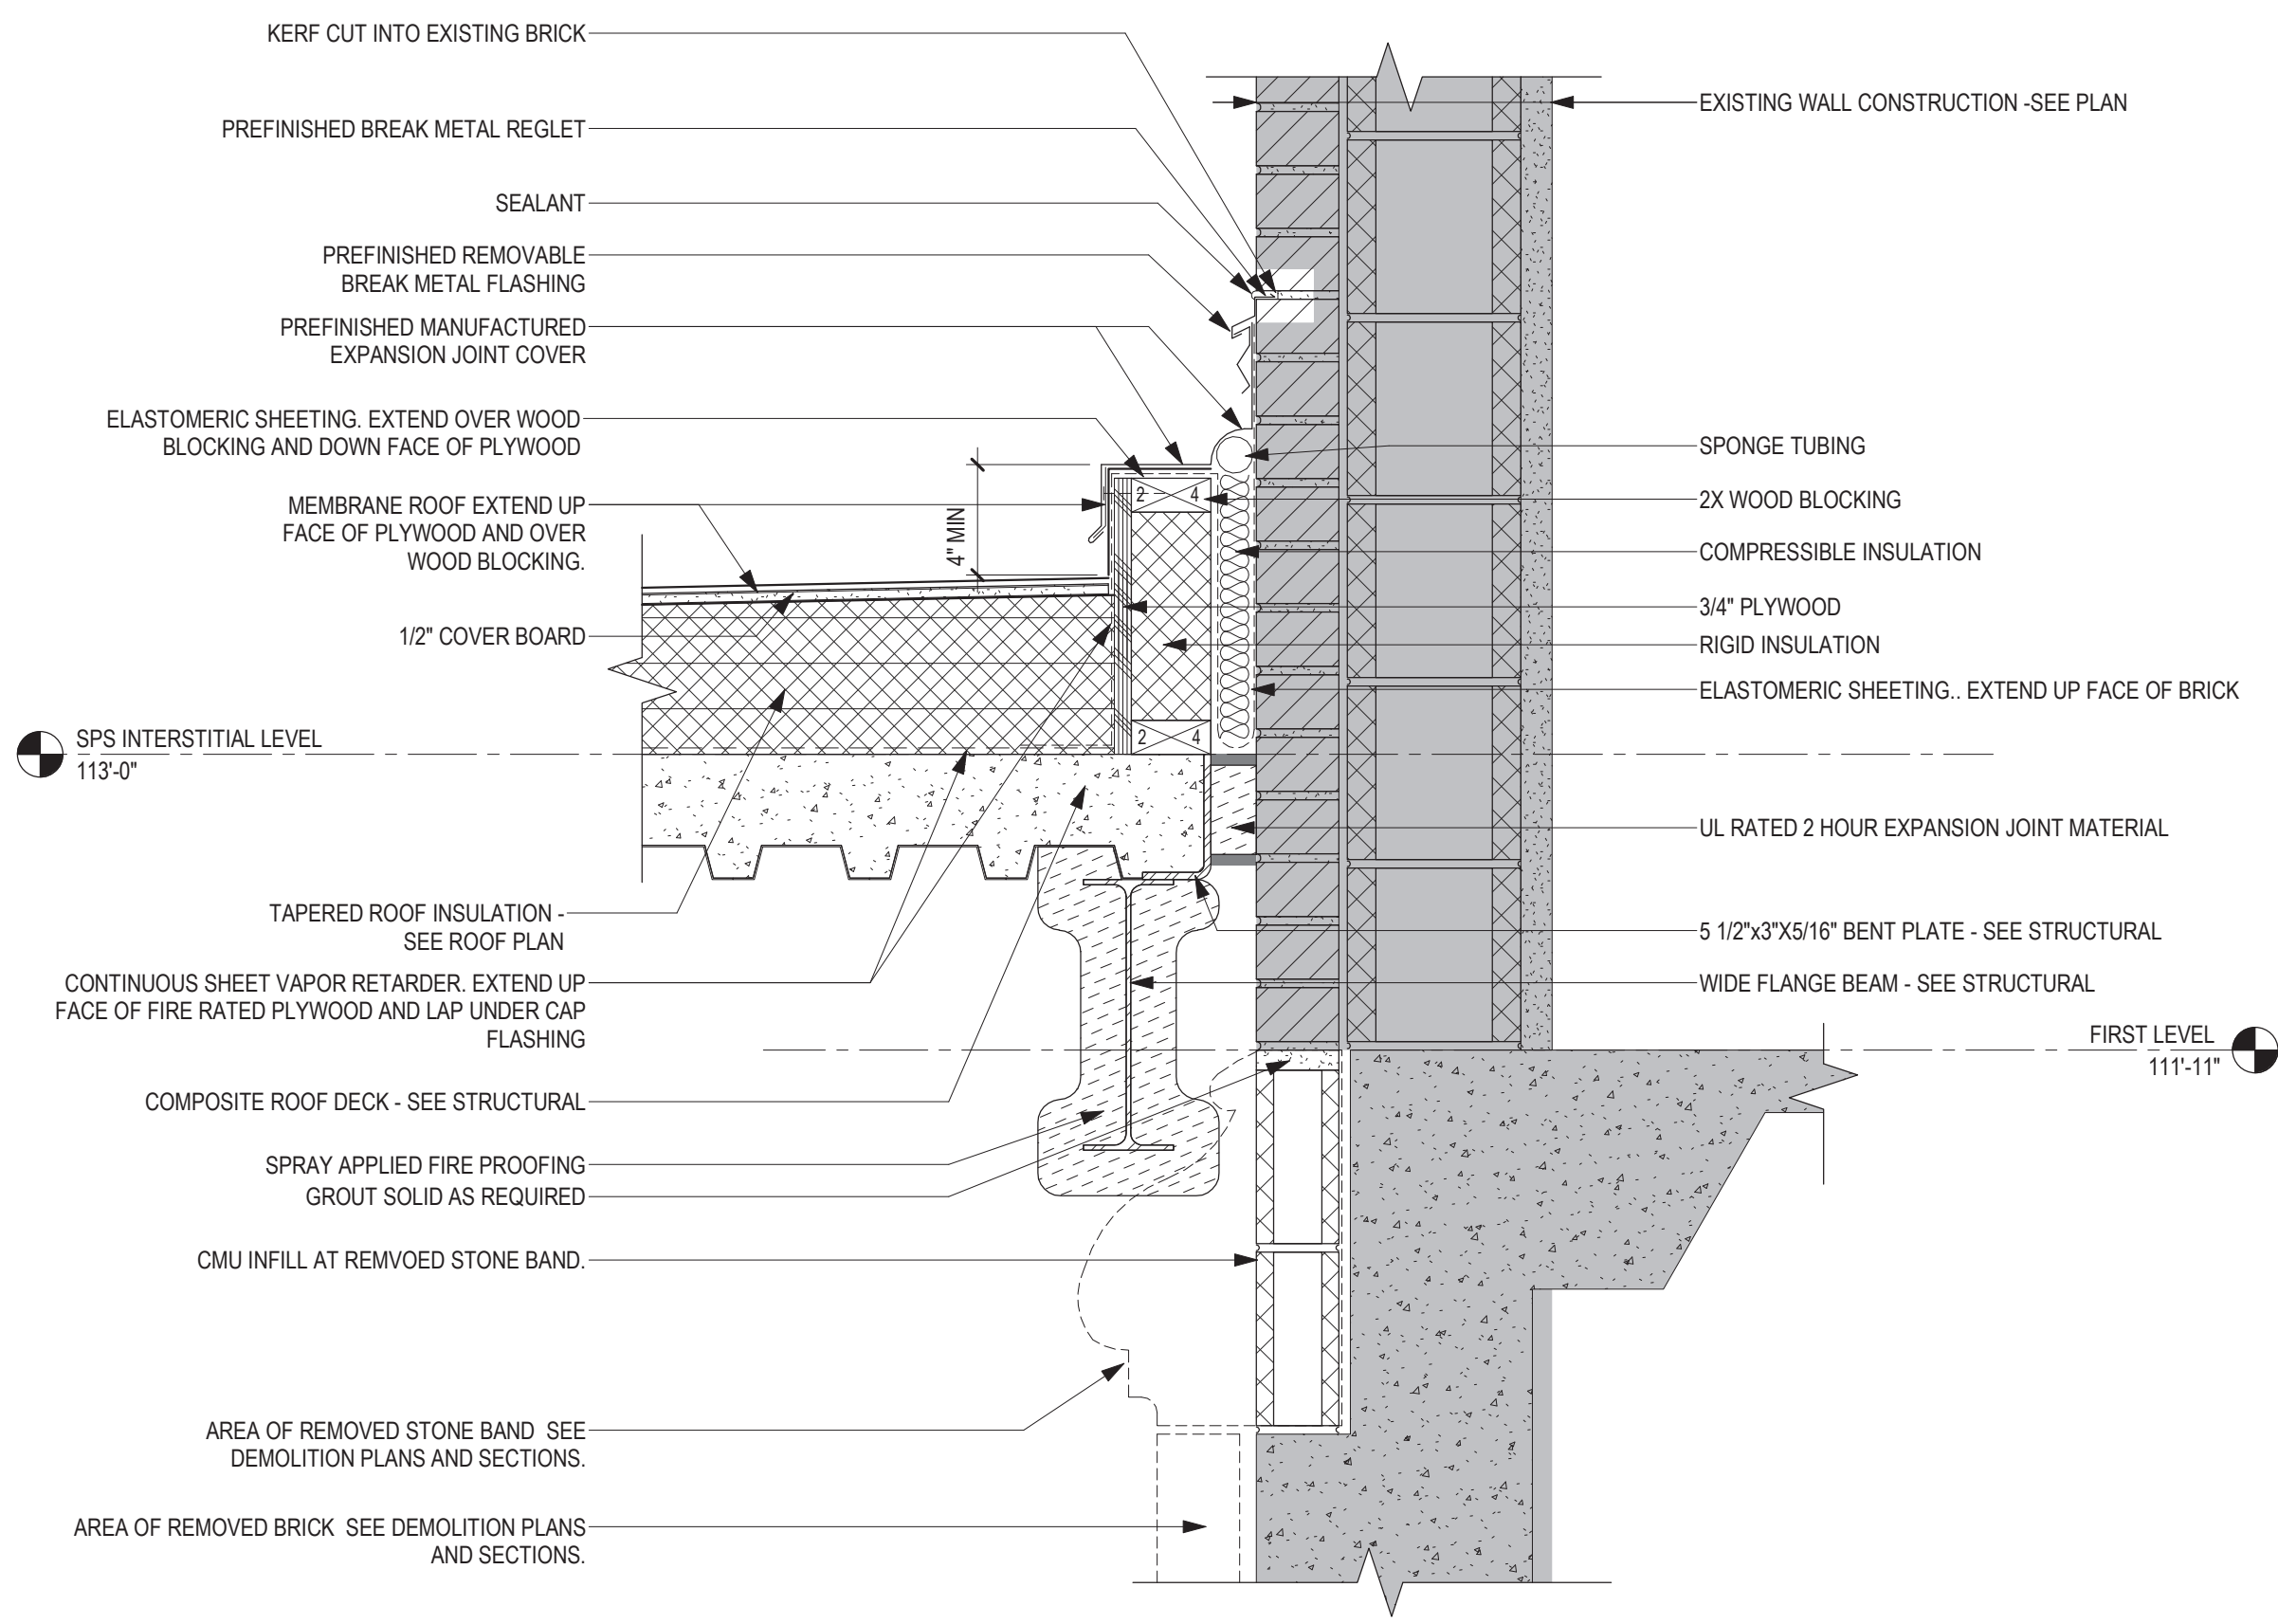


3 ROOF DETAIL - MEMBRANE ROOF @ EXISTING BRICK
1 1/2" = 1'-0"

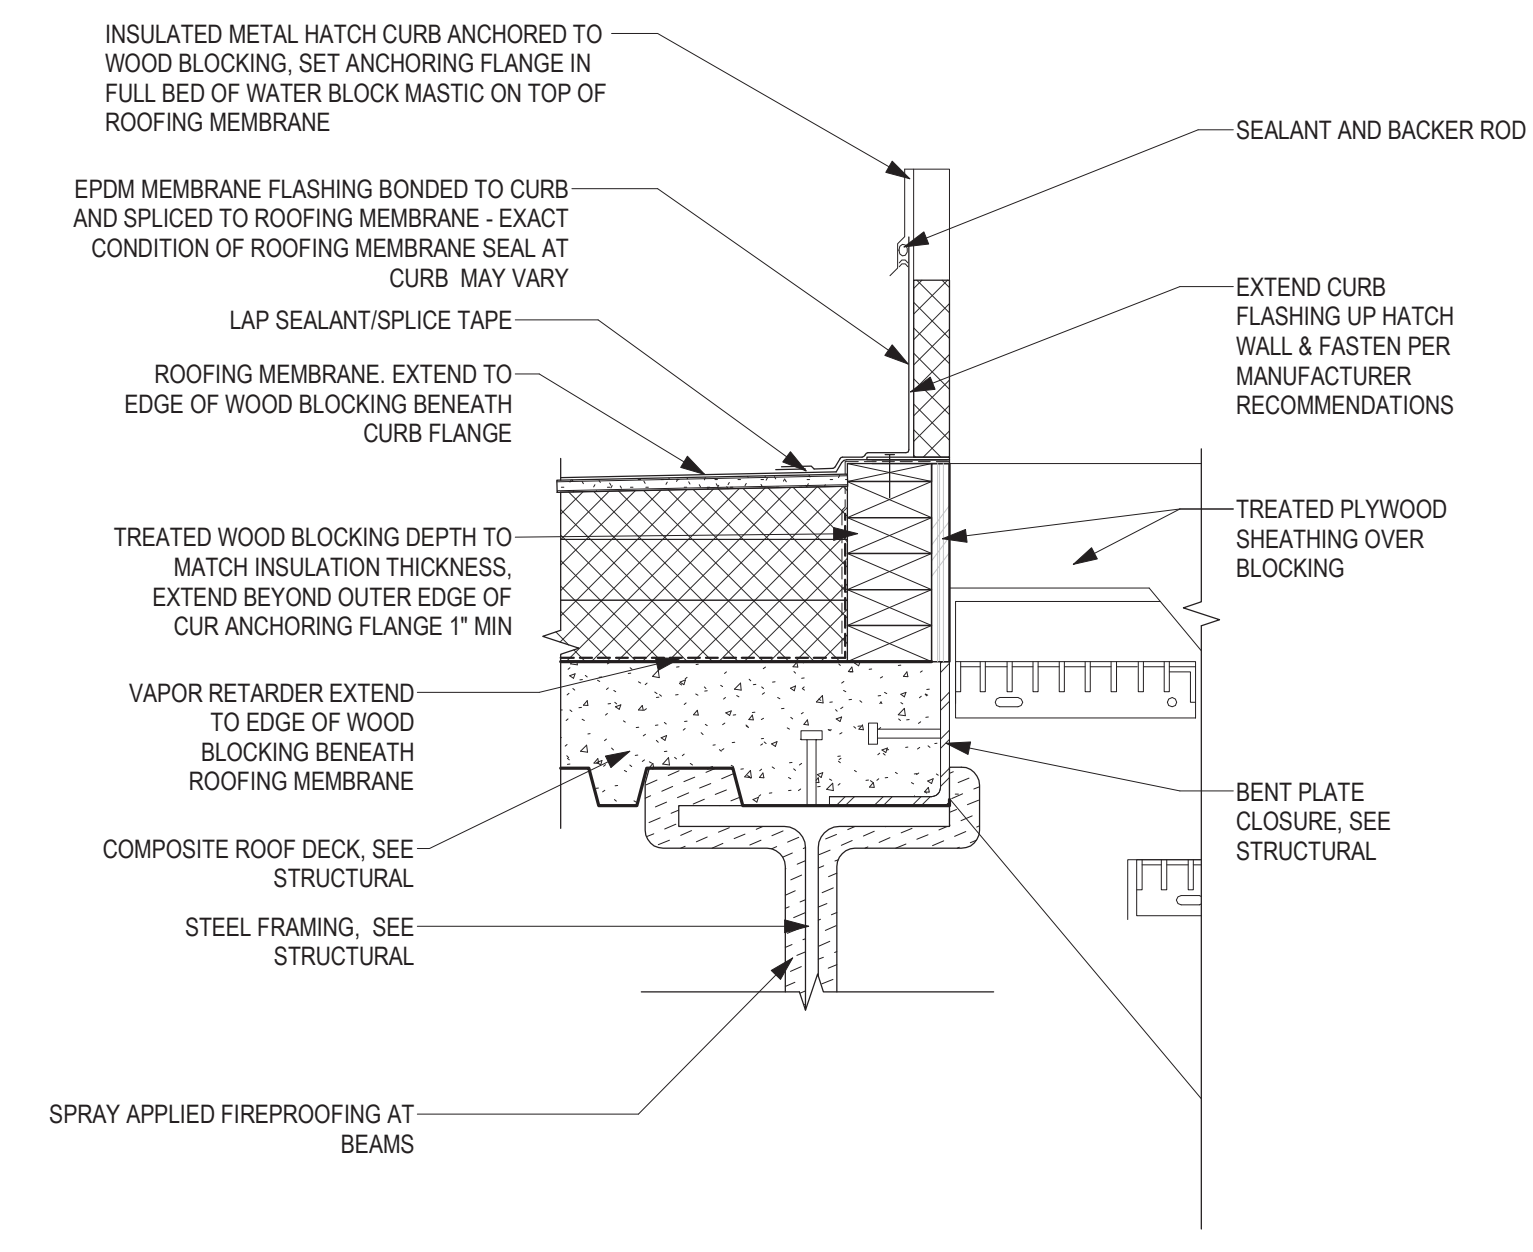


2 ROOF DETAIL - ROOF HATCH CURB
1 1/2" = 1'-0"

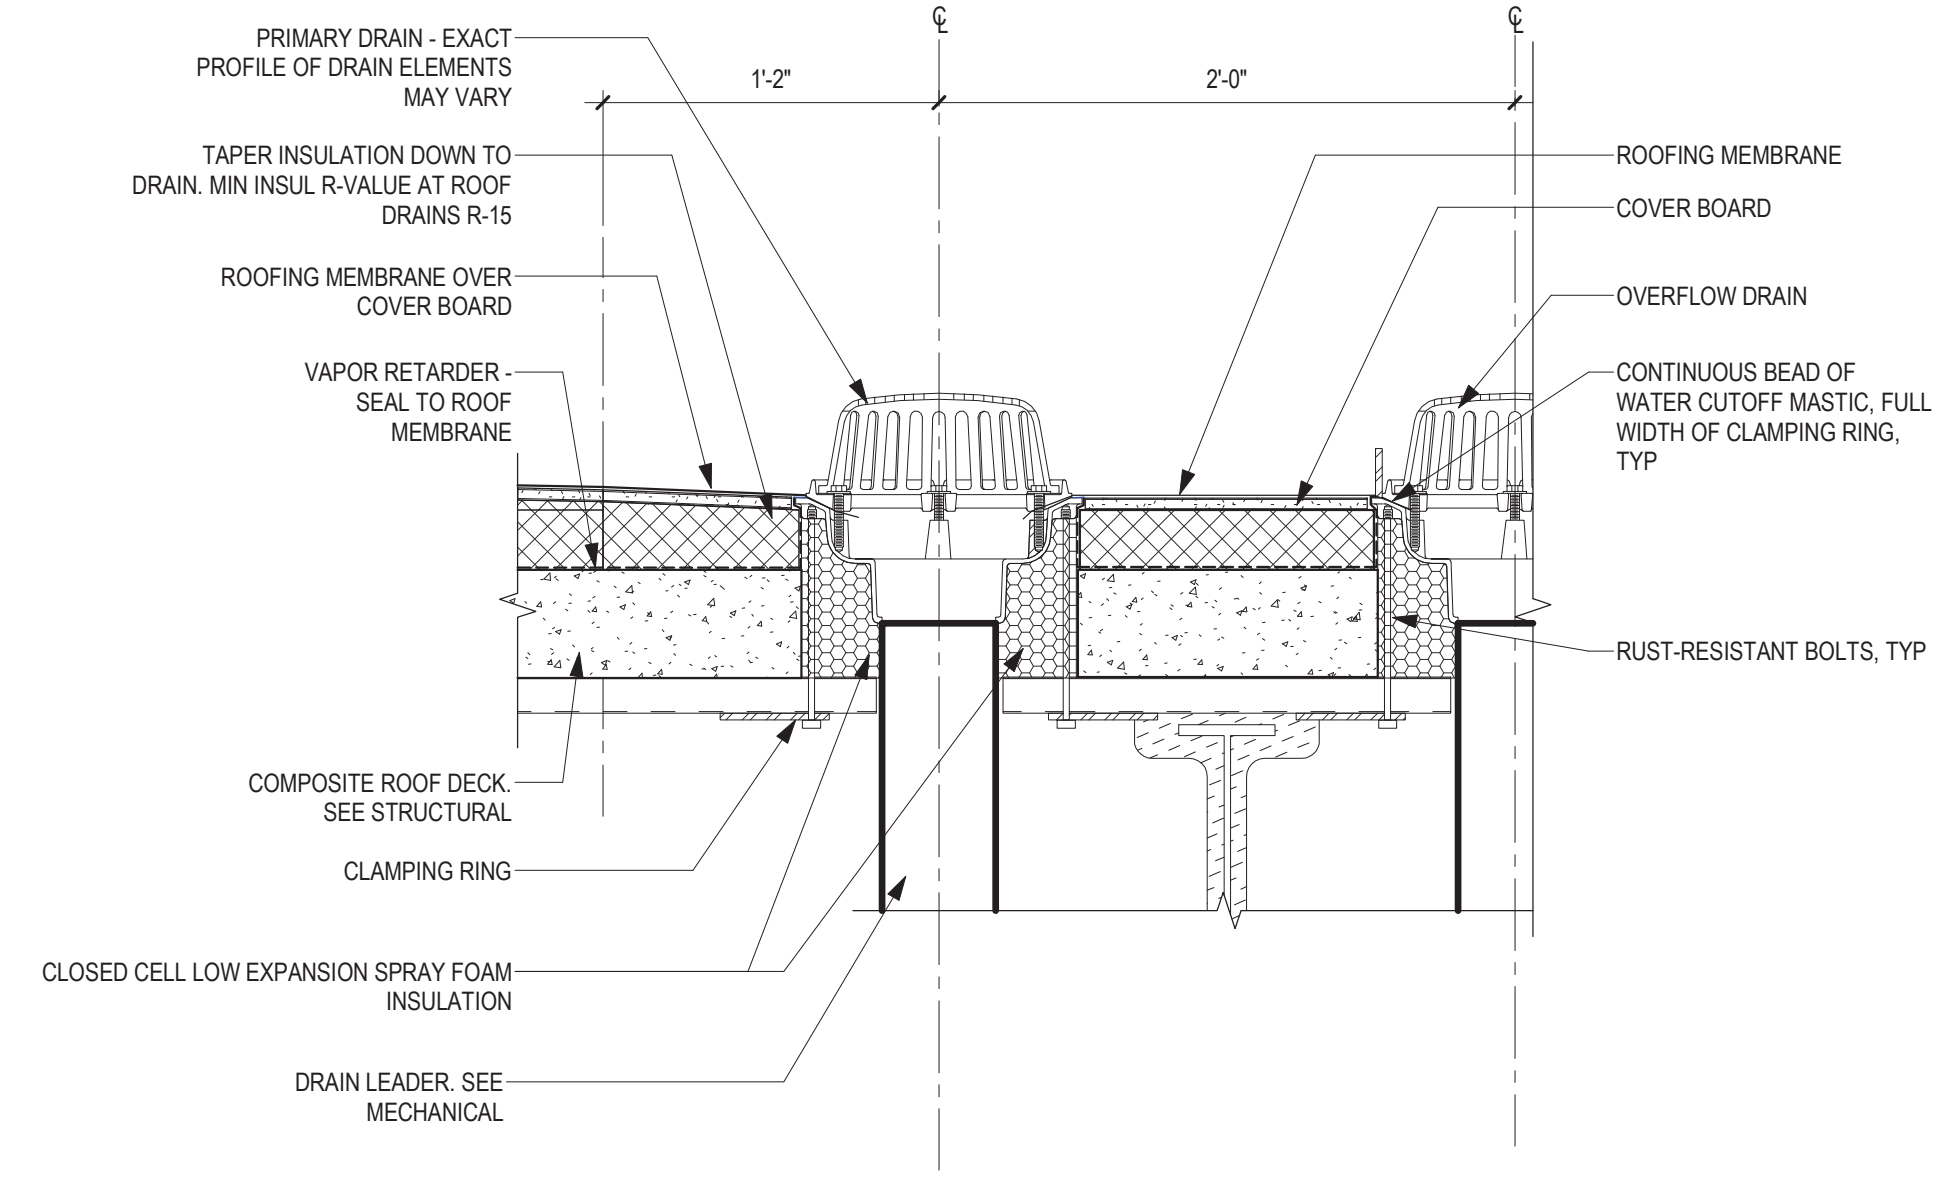


1 SECTION DETAIL - ROOF DRAINS
1 1/2" = 1'-0"

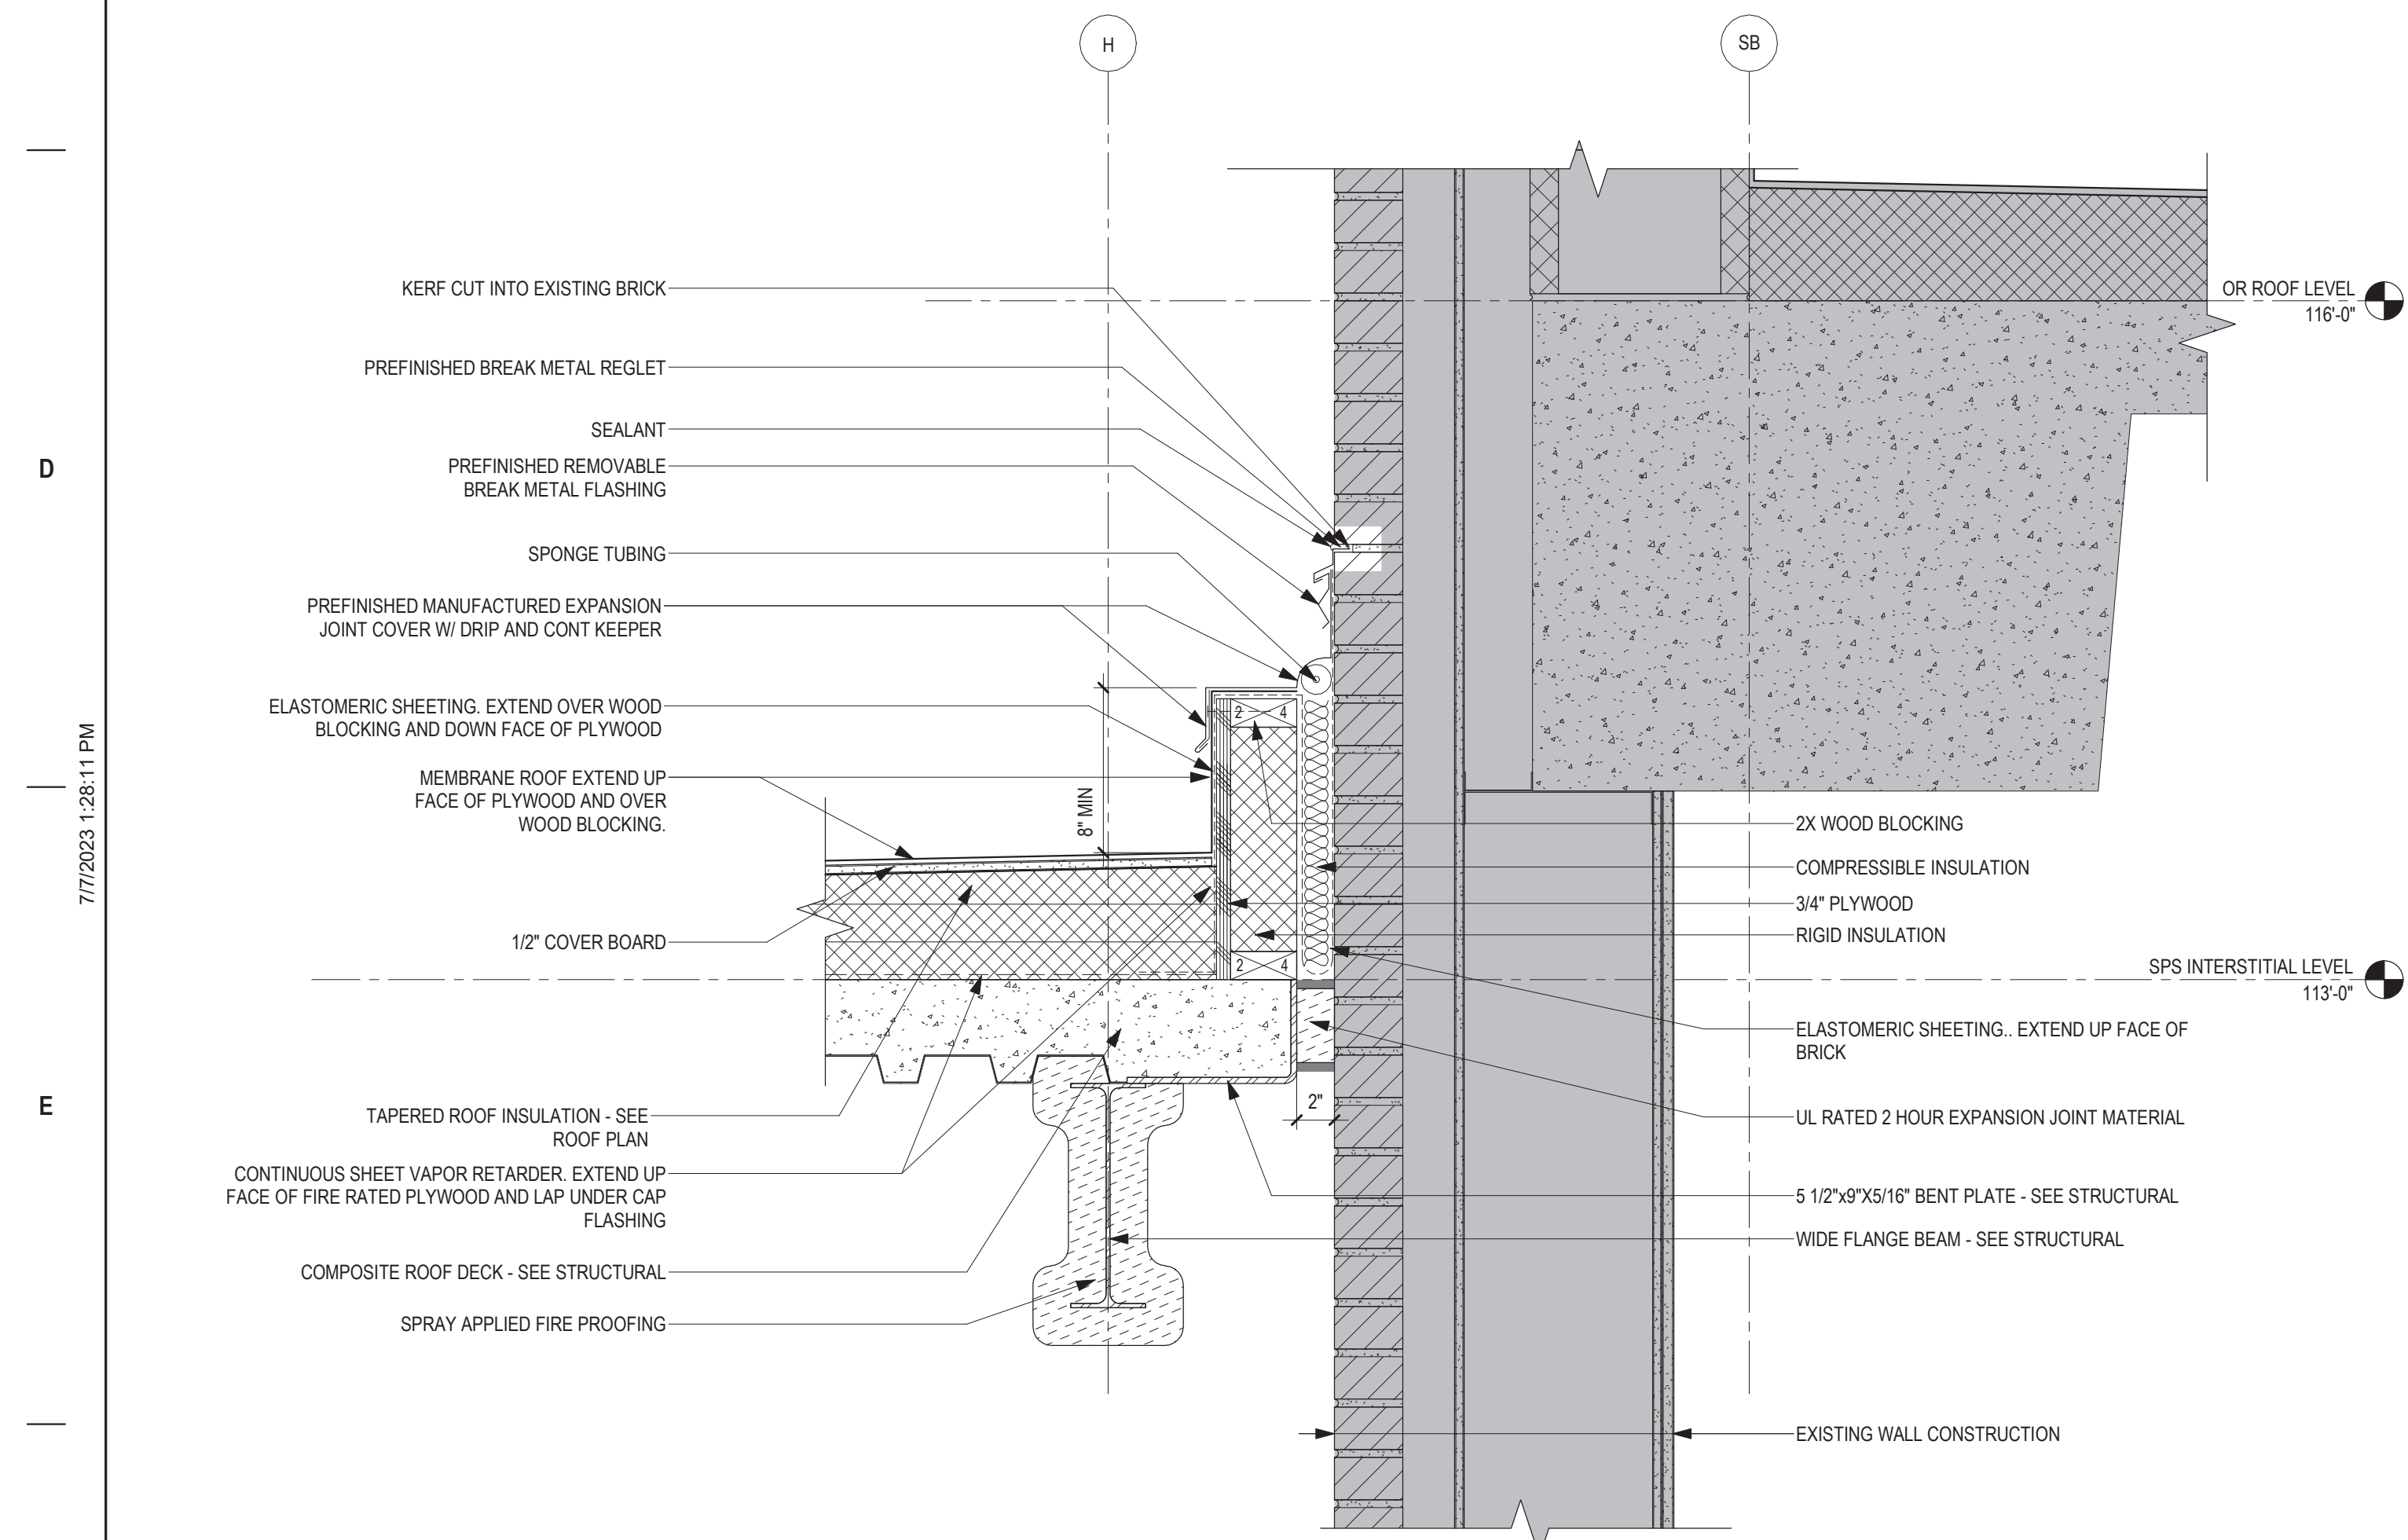

6 ROOF DETAIL - MEMBRANE ROOF @ OPERATING ROOM SUITE
1 1/2" = 1'-0"

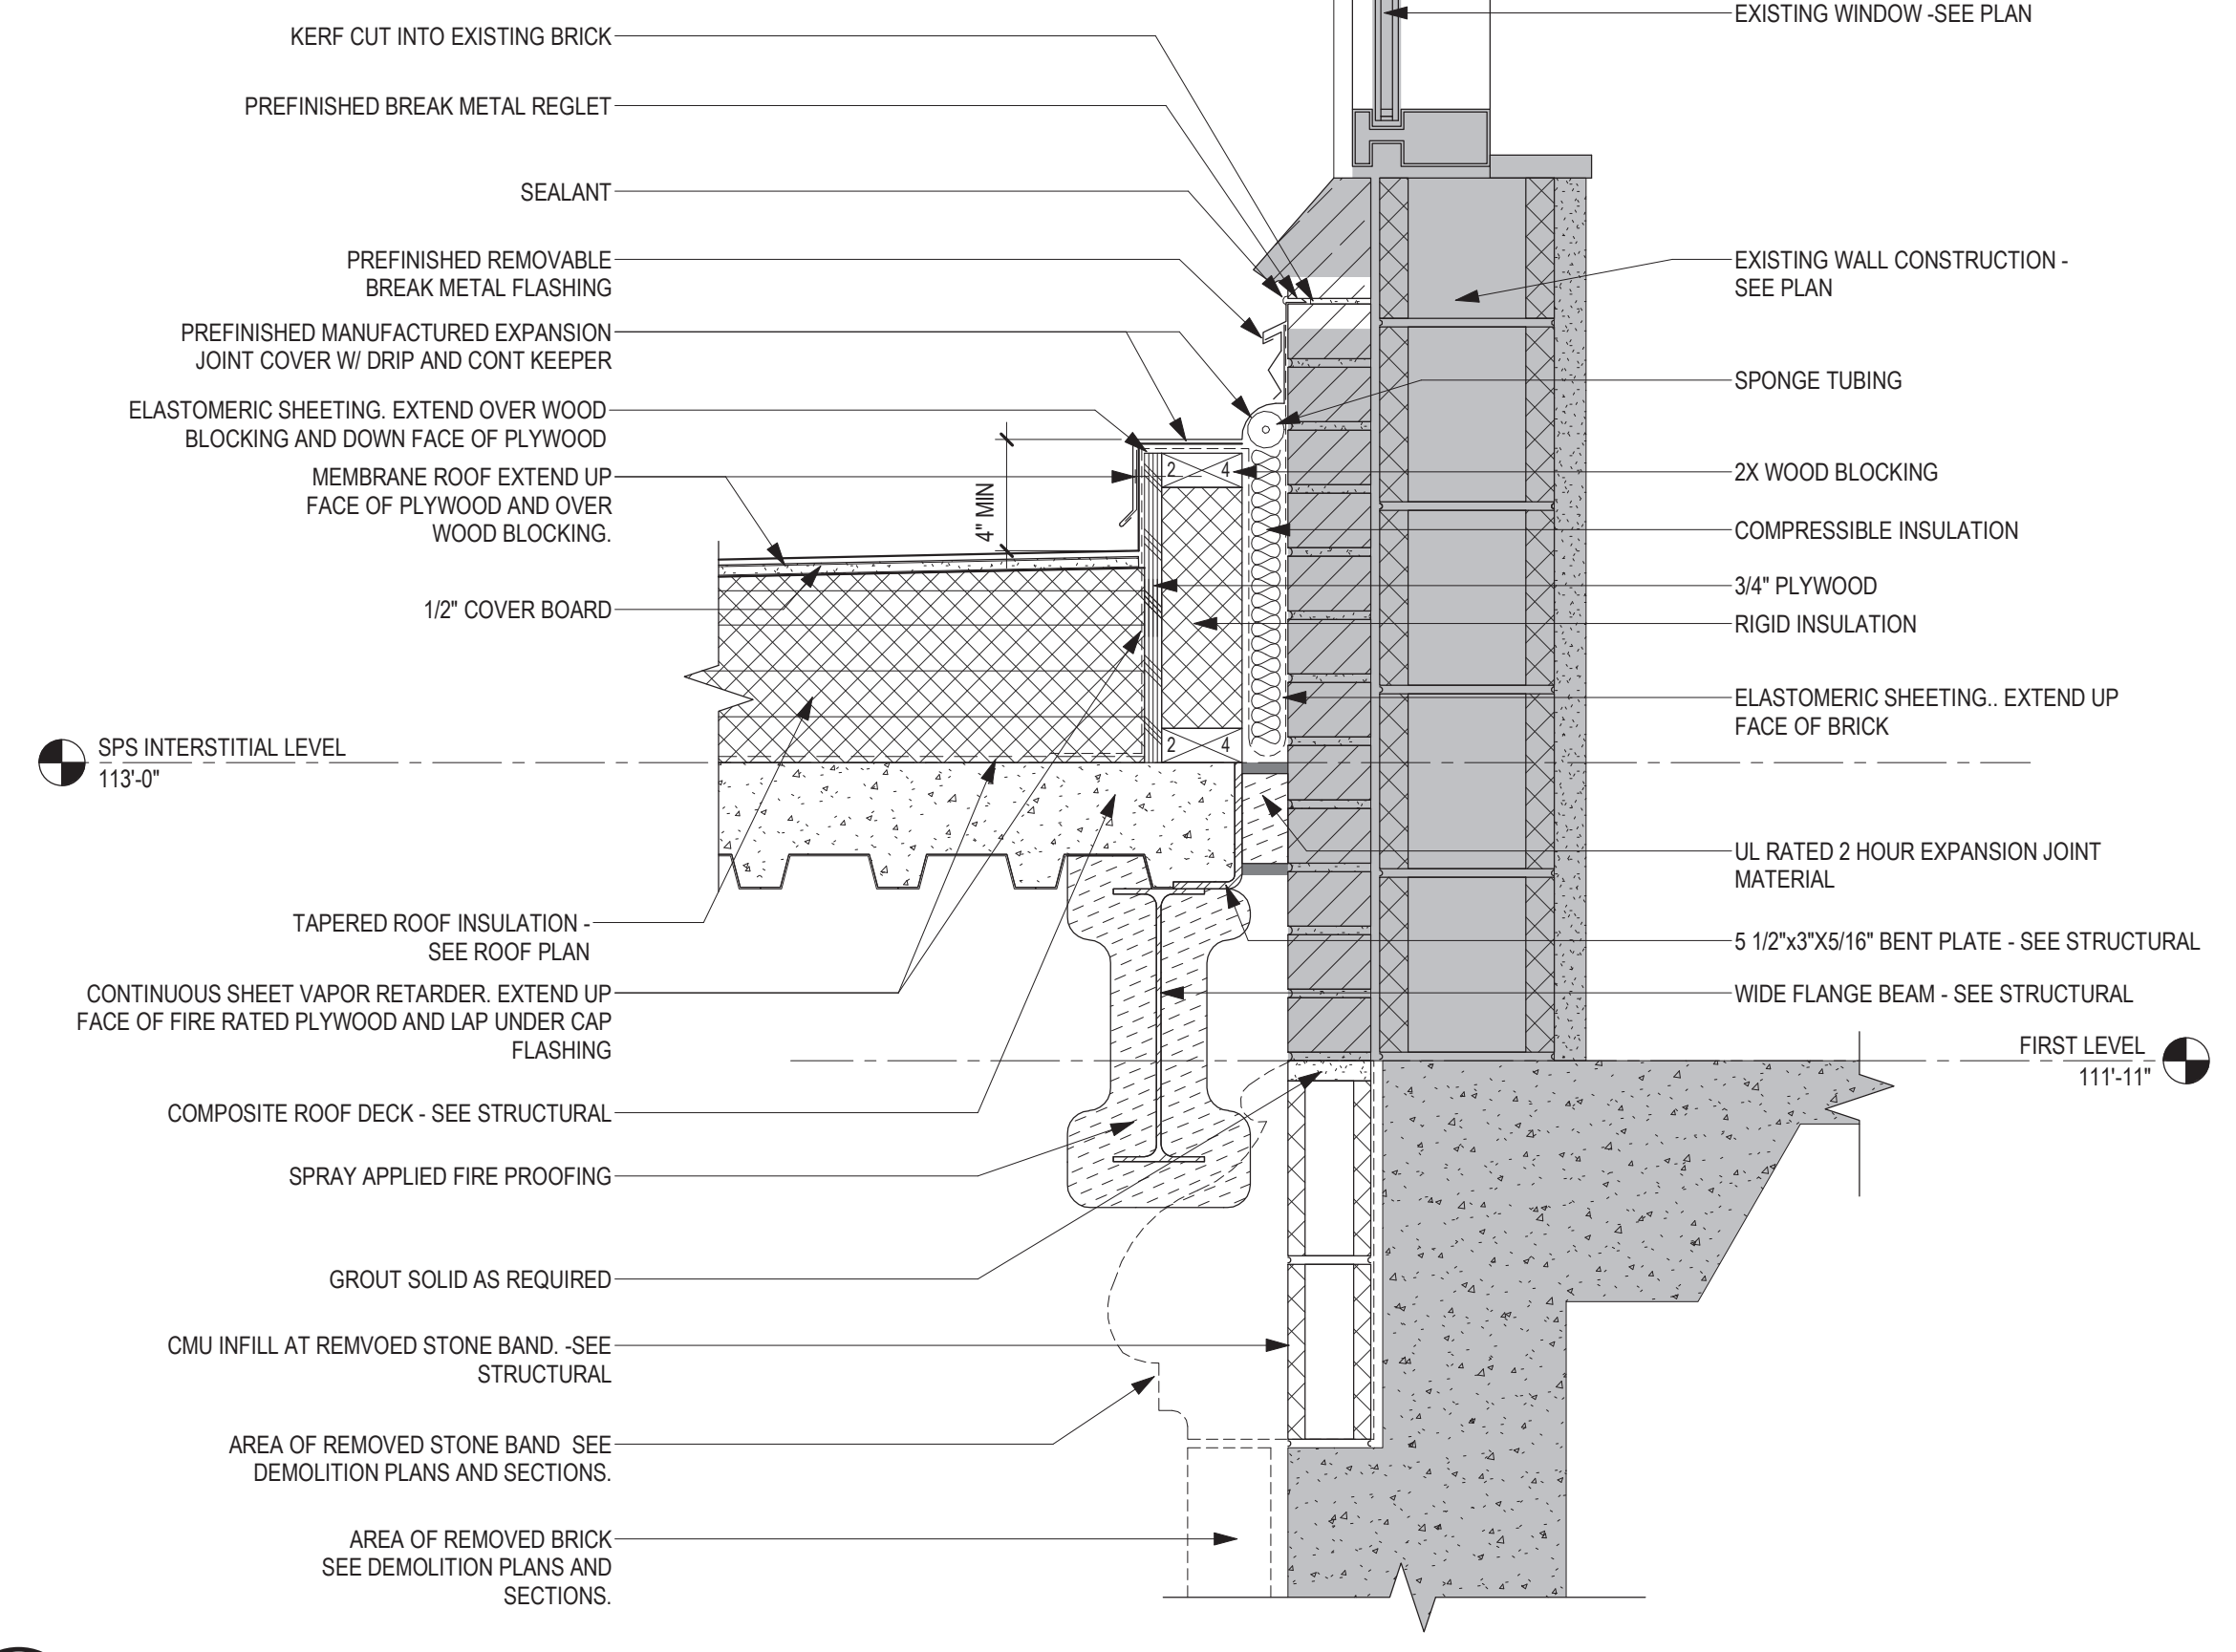

5 ROOF DETAIL - MEMBRANE ROOF @ FIRST LEVEL WINDOW
1 1/2" = 1'-0"

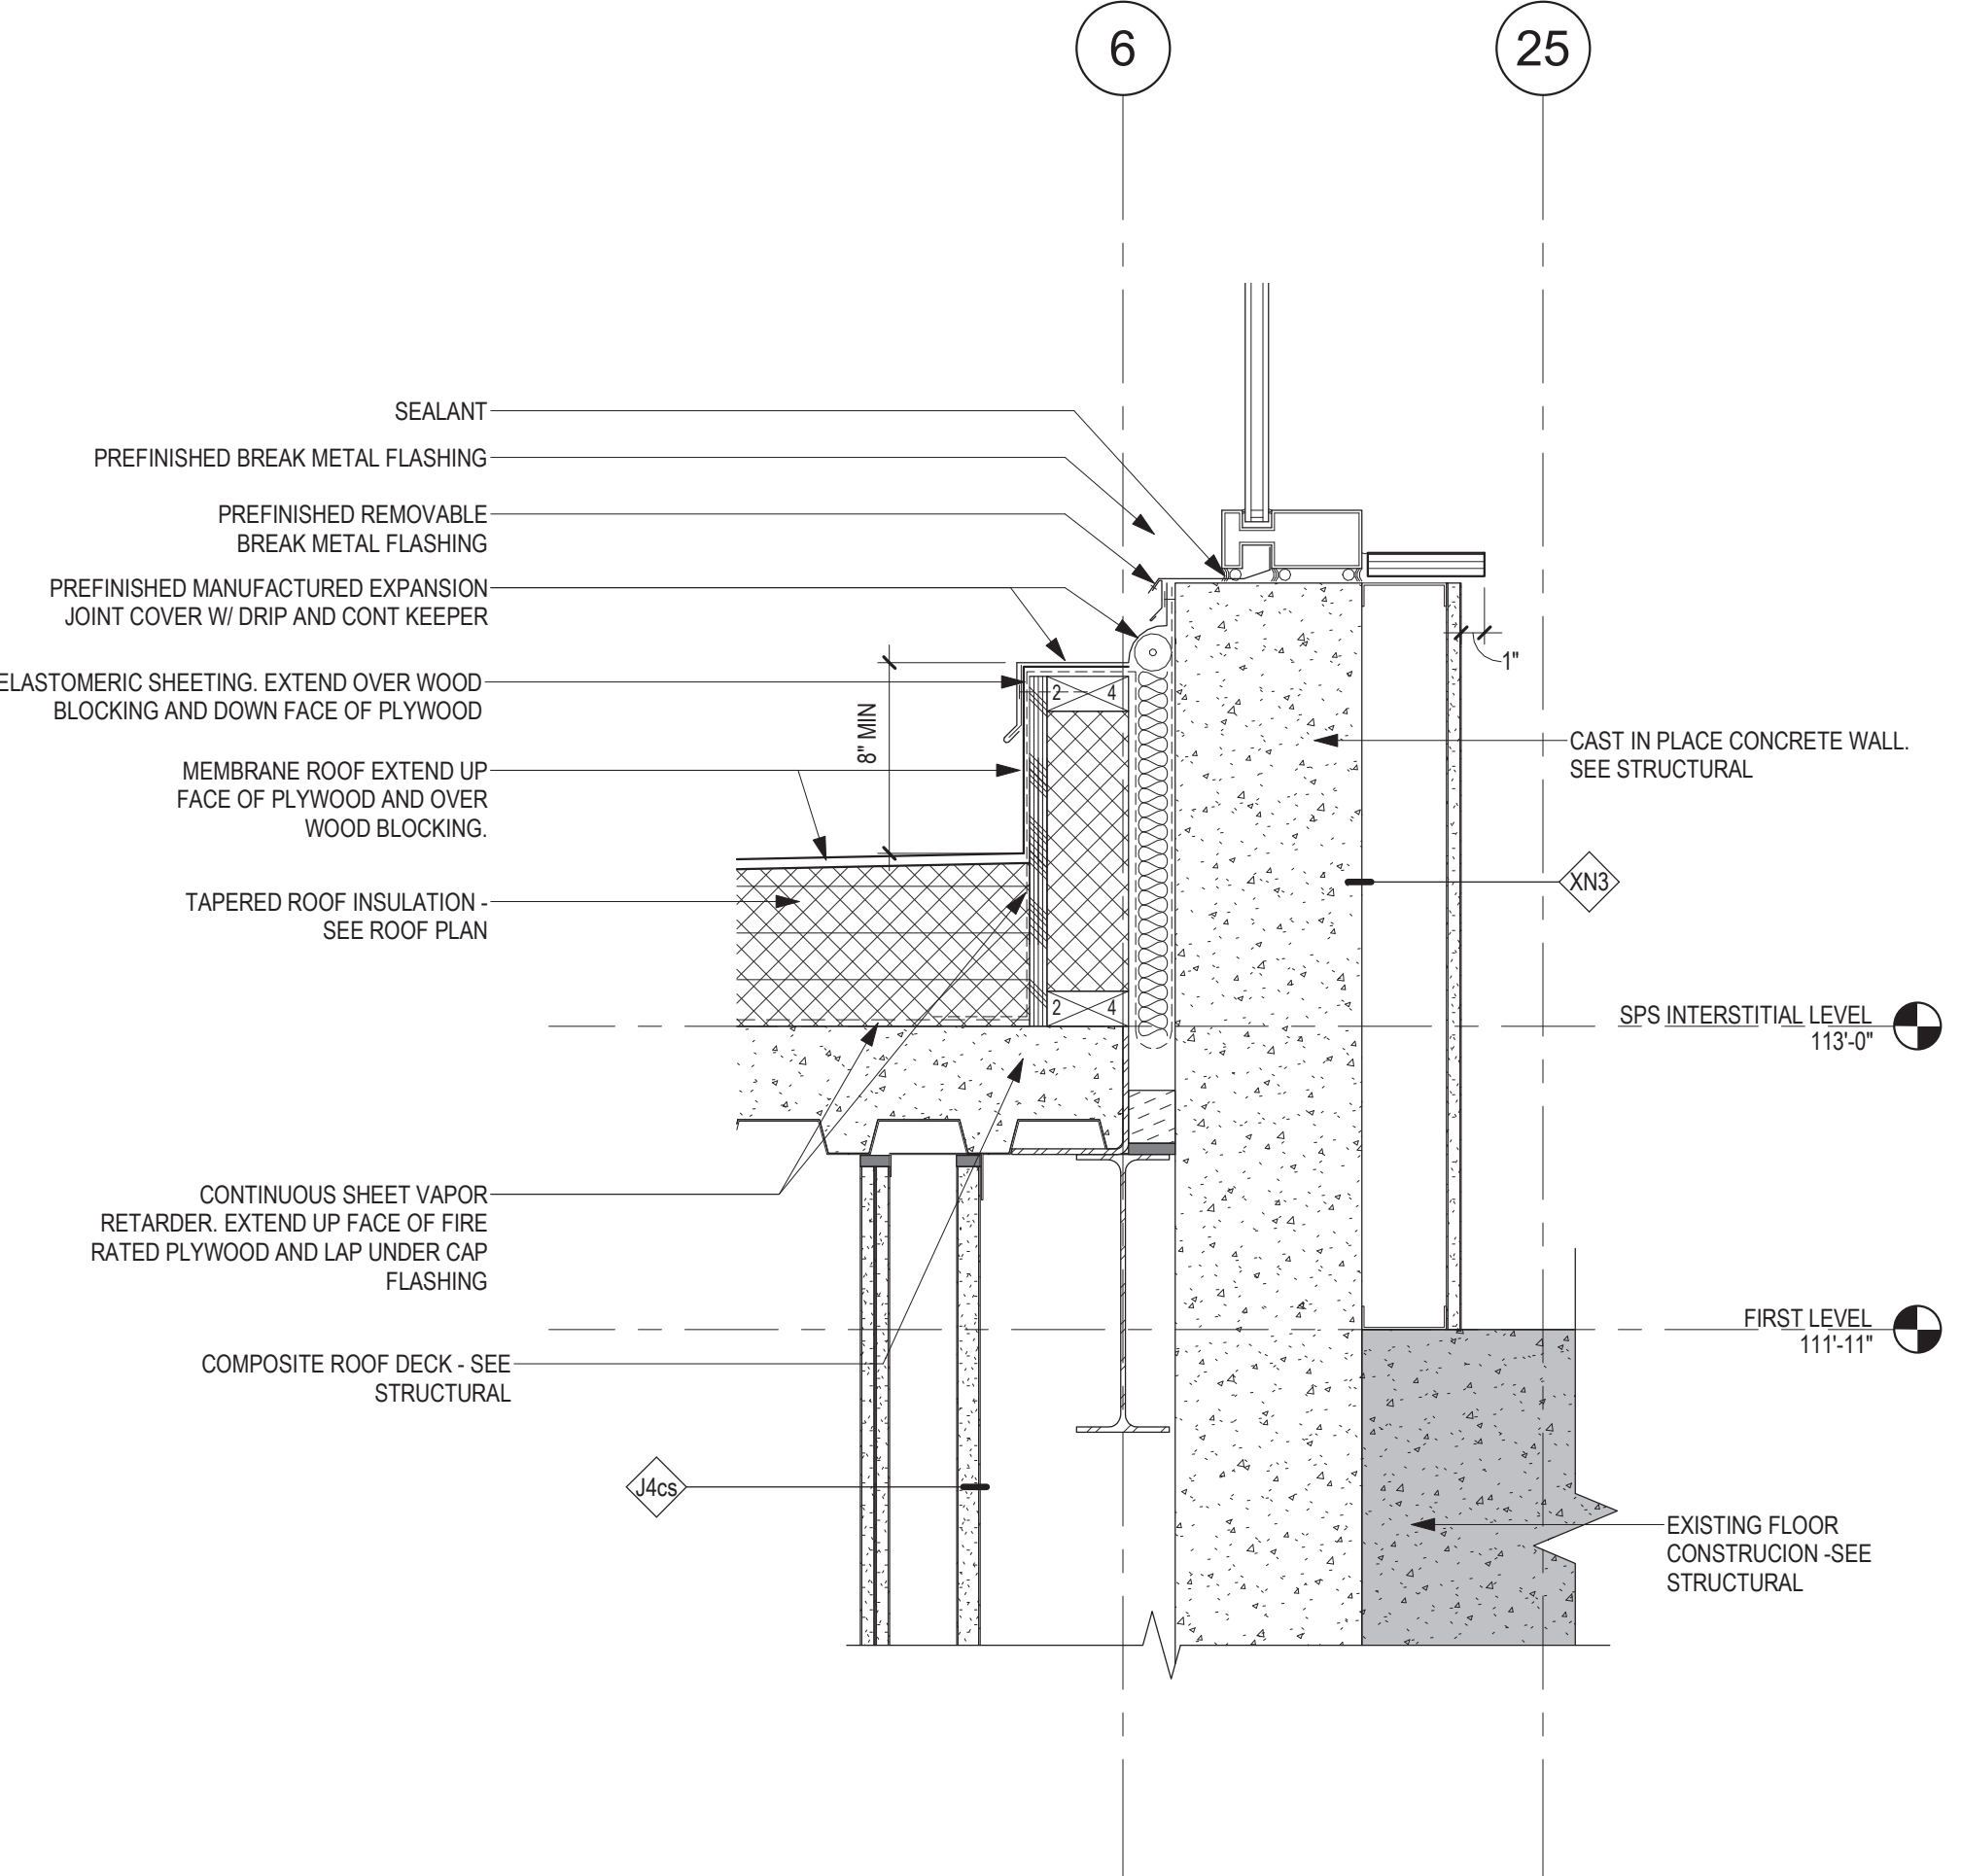

4 ROOF DETAIL - ROOF ANT MODIFIED CURTIAN WALL
1 1/2" = 1'-0"

Revisions:	Date:

CONSULTANT

ARCHITECT/ENGINEER OF RECORD

13605 1st Ave. N. #100 Plymouth, MN 55441
P 763.412.4000 | F 763.412.4090 | ae-mn.com
Anderson Engineering of Minnesota, LLC | Proj # 16584

Office of Construction and Facilities Management

U.S. Department of Veterans Affairs

Drawing Title

ROOF DETAILS

Approved:

Phase

BID DOCUMENTS

FULLY SPRINKLERED

Project Title

CONSTRUCT NEW SPS

Location

Sioux Falls, SD.

Issue Date

08/04/2022

Checked

Checker

Drawn

Author

Project Number

438-460

Building Number

5

Drawing Number

AE530

A

B

C

D

E

F

7/7/2023 1:28:13 PM

C:\Users\Public\Documents\Revit Projects\16584-RCT1_gbarani@ae-mn.com.rvt

A


B

C


D

E


F

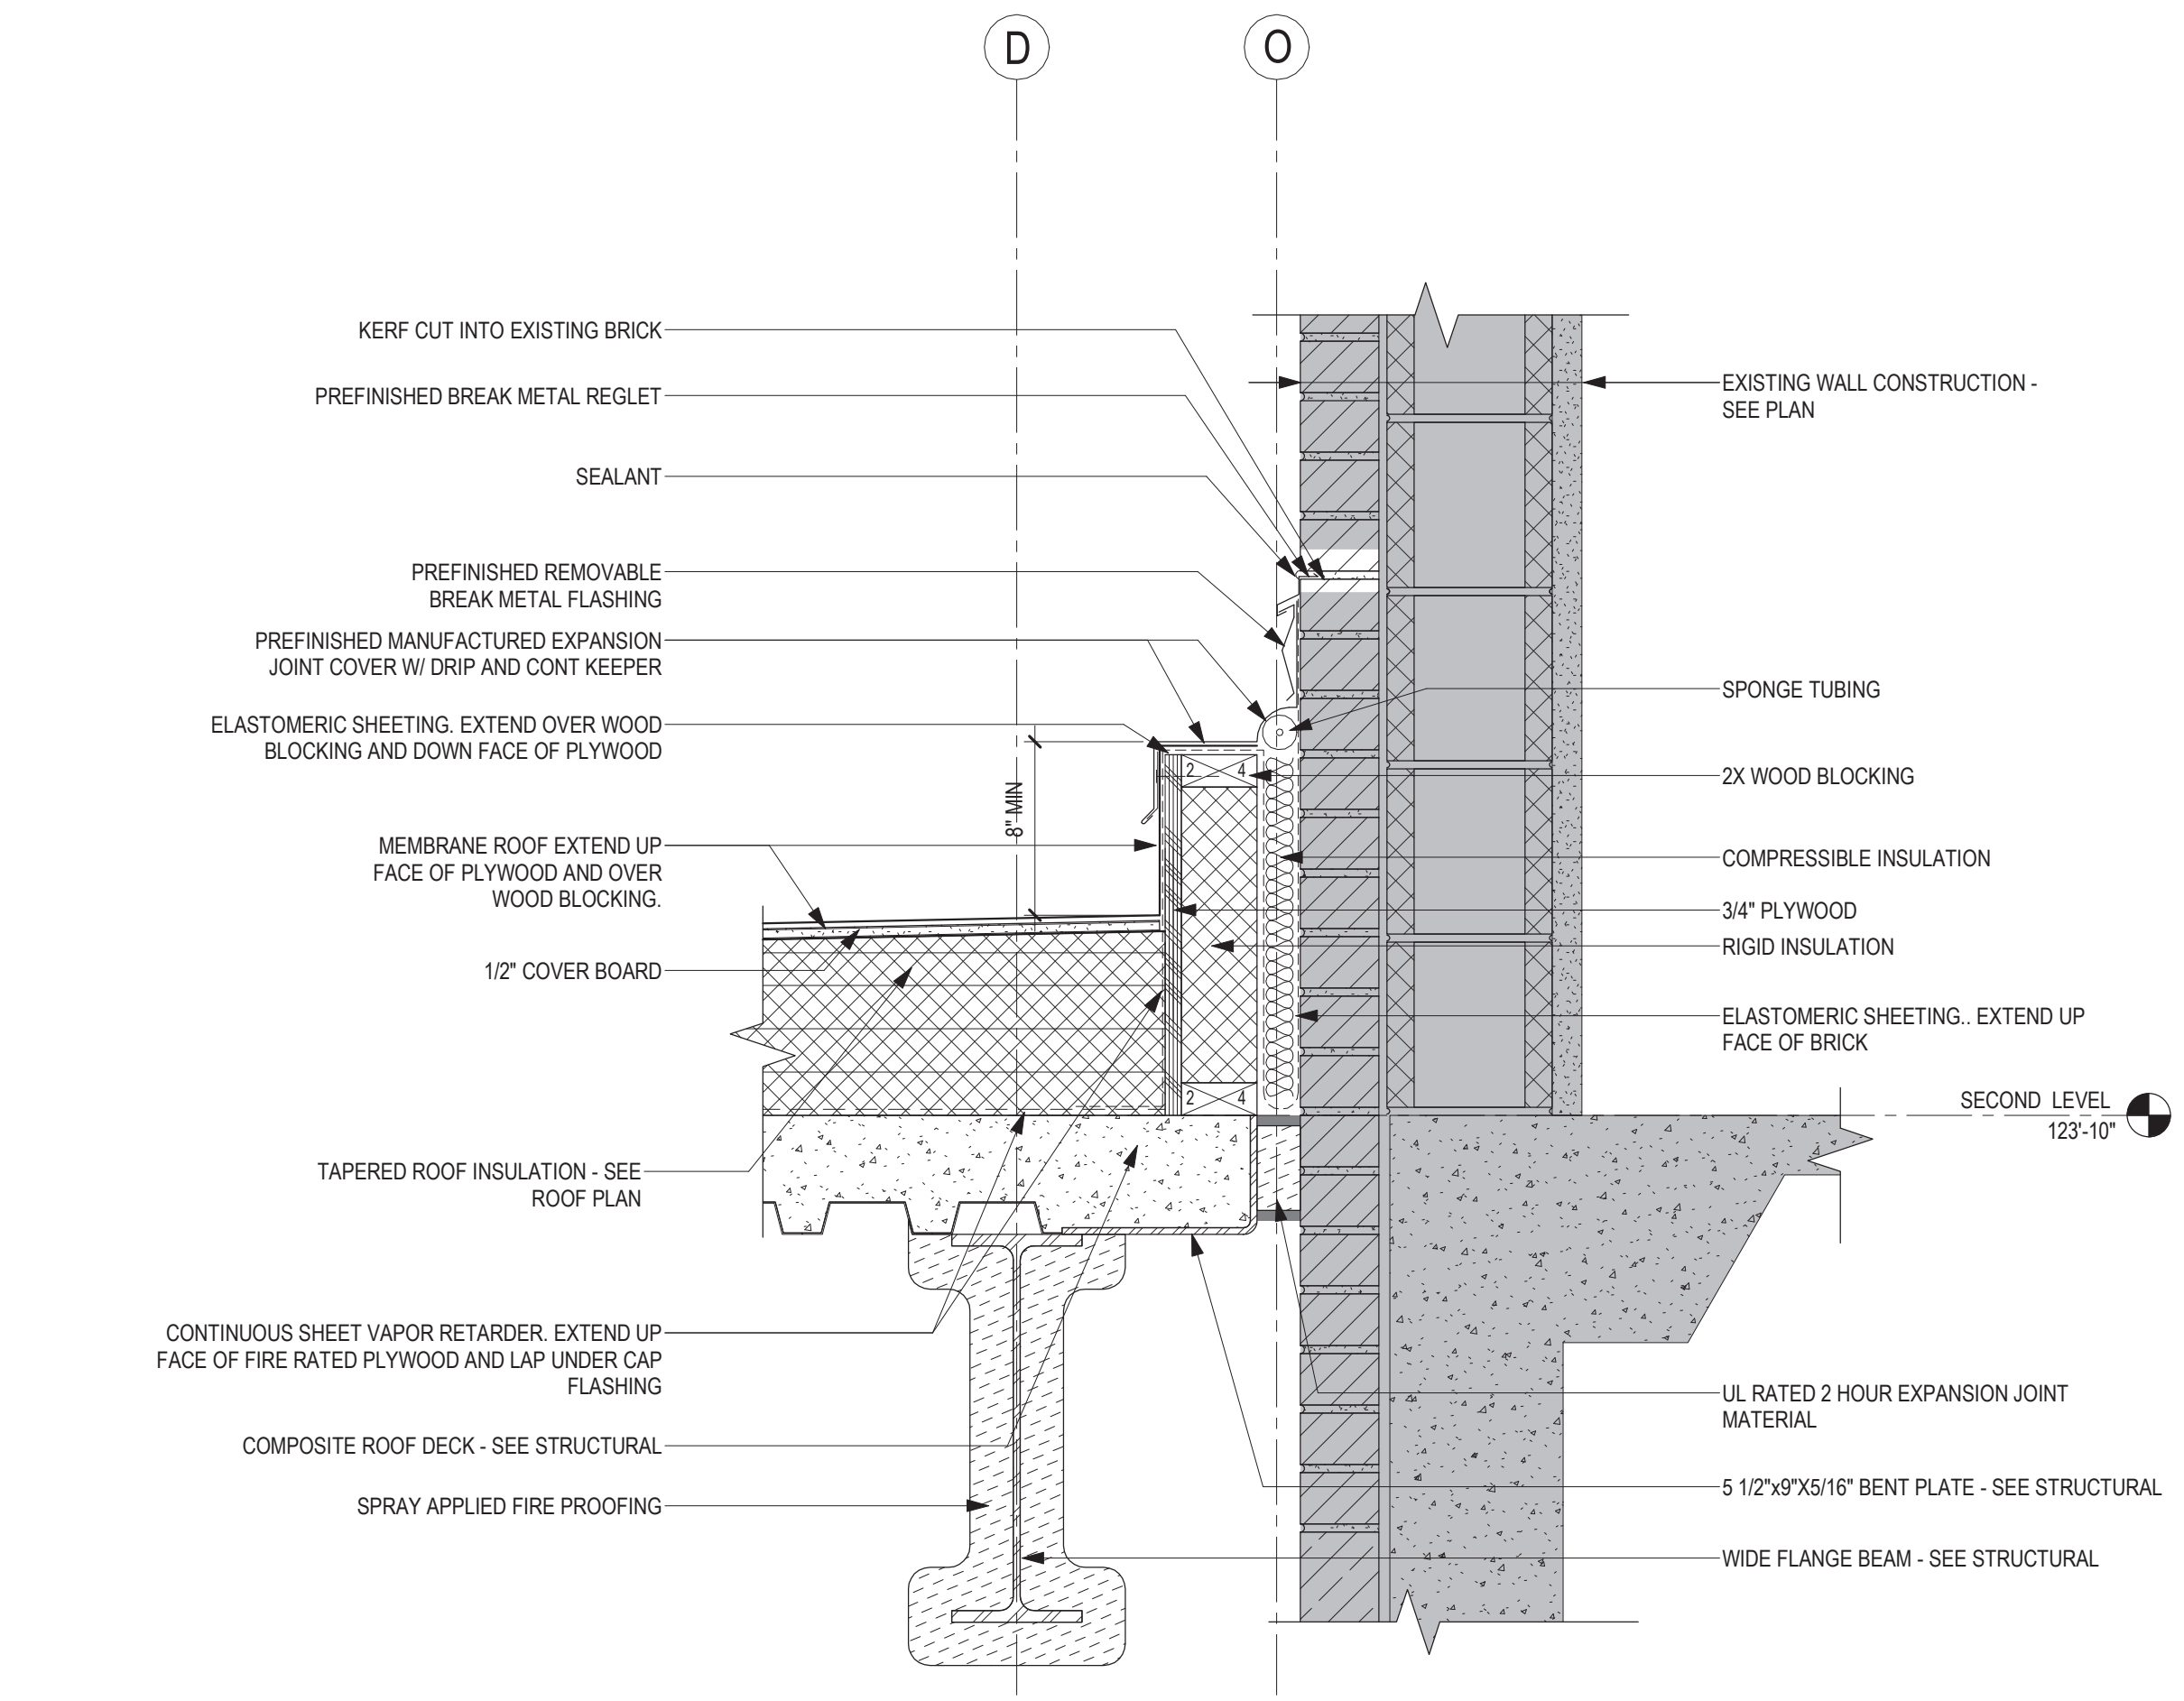

2 ROOF DETAIL - MEMBRANE ROOF @ EXISTING SECOND LEVEL
1 1/2" = 1'-0"

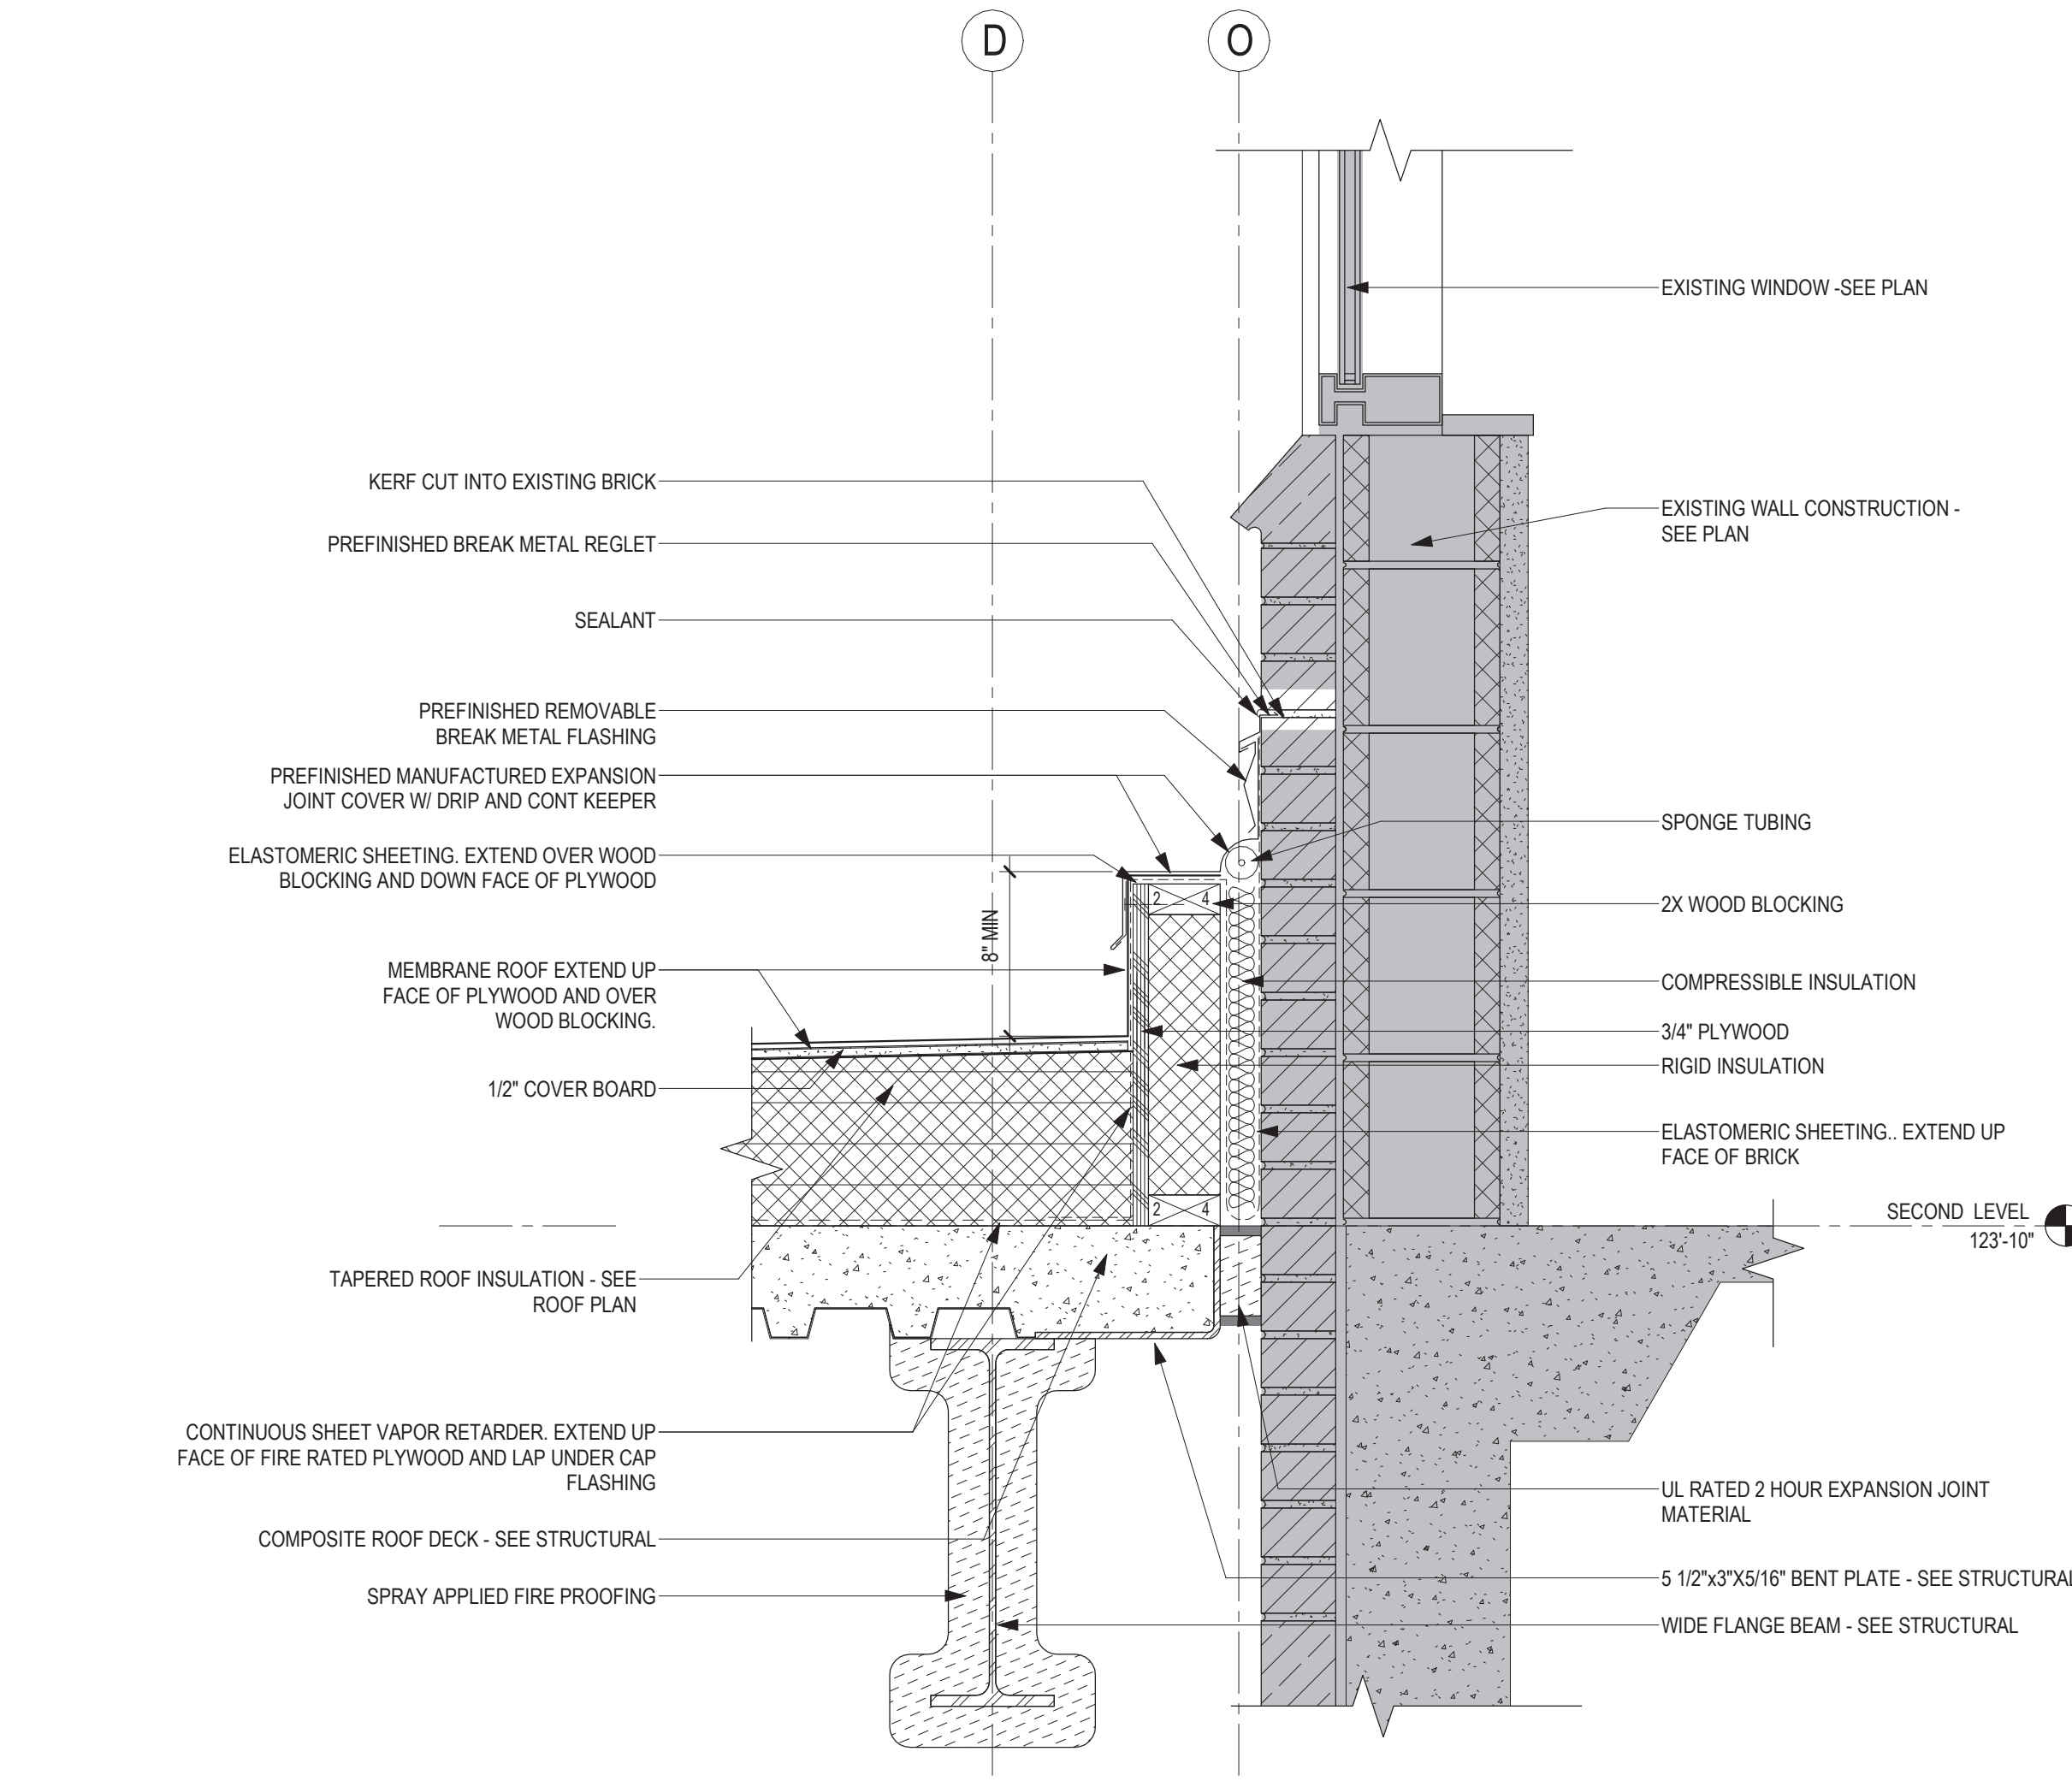

1 ROOF DETAIL - MEMBRANE ROOF @ EXISTING SECOND LEVEL WINDOW
1 1/2" = 1'-0"

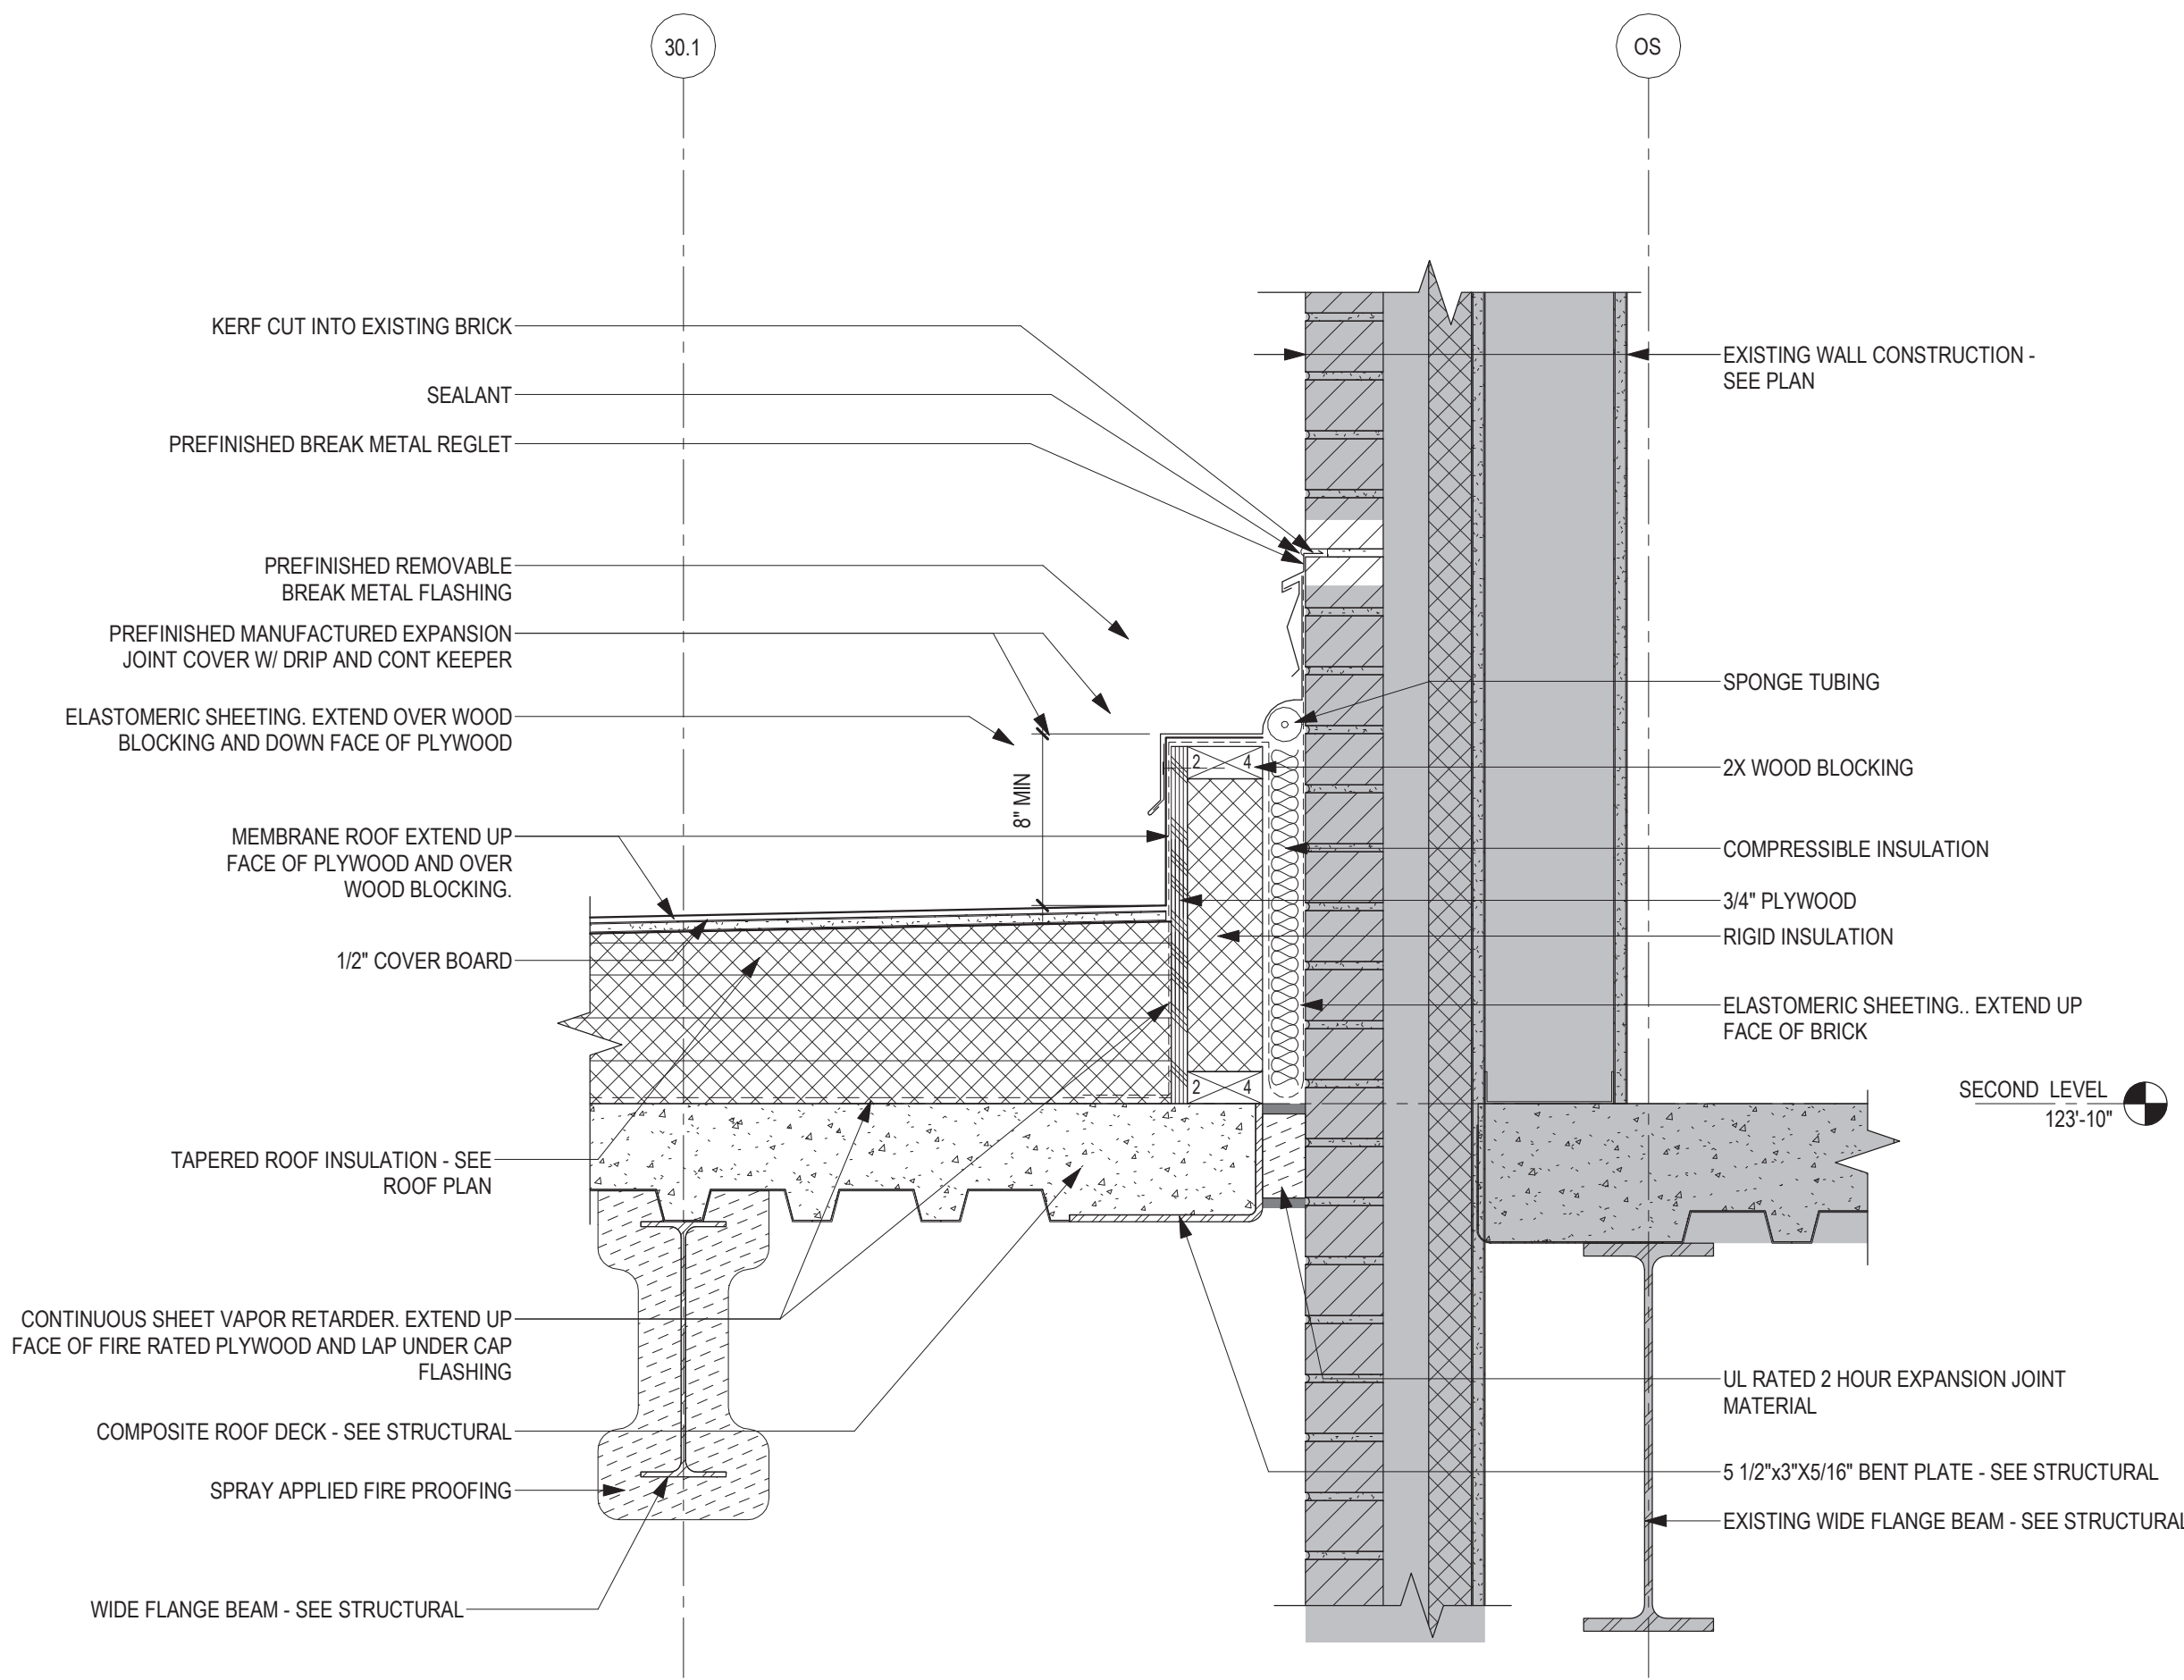

3 ROOF DETAIL - MEMBRANE ROOF @ INPATIENT ADDITION - GRID OS
1 1/2" = 1'-0"

Revisions:	Date:

CONSULTANT

IMEG

ARCHITECT/ENGINEER OF RECORD

ANDERSON

13605 1st Ave. N. #100 Plymouth, MN 55441
P 763.412.4000 | F 763.412.4090 | ae-mn.com
Anderson Engineering of Minnesota, LLC | Proj # 16584

STAMP

DATE: 08/04/2022
License # 9335

Office of Construction and Facilities Management

VA U.S. Department of Veterans Affairs

Drawing Title

ROOF DETAILS

Approved:

Phase

BID DOCUMENTS

FULLY SPRINKLERED

Project Title

CONSTRUCT NEW SPS

Location
Sioux Falls, SD.

Issue Date
08/04/2022

Checked
Checker

Drawn
Author

Project Number
438-460

Building Number
5

Drawing Number
AE531

A

B

C


D

E


F

7/7/2023 1:28:16 PM
C:\Users\Public\Documents\Revit Projects\16584-R21_gbarani@ae-mn.com.rvt


7/7/2023 1:28:16 PM
C:\Users\Public\Documents\Revit Projects\16584-R21_gbarani@ae-mn.com.rvt

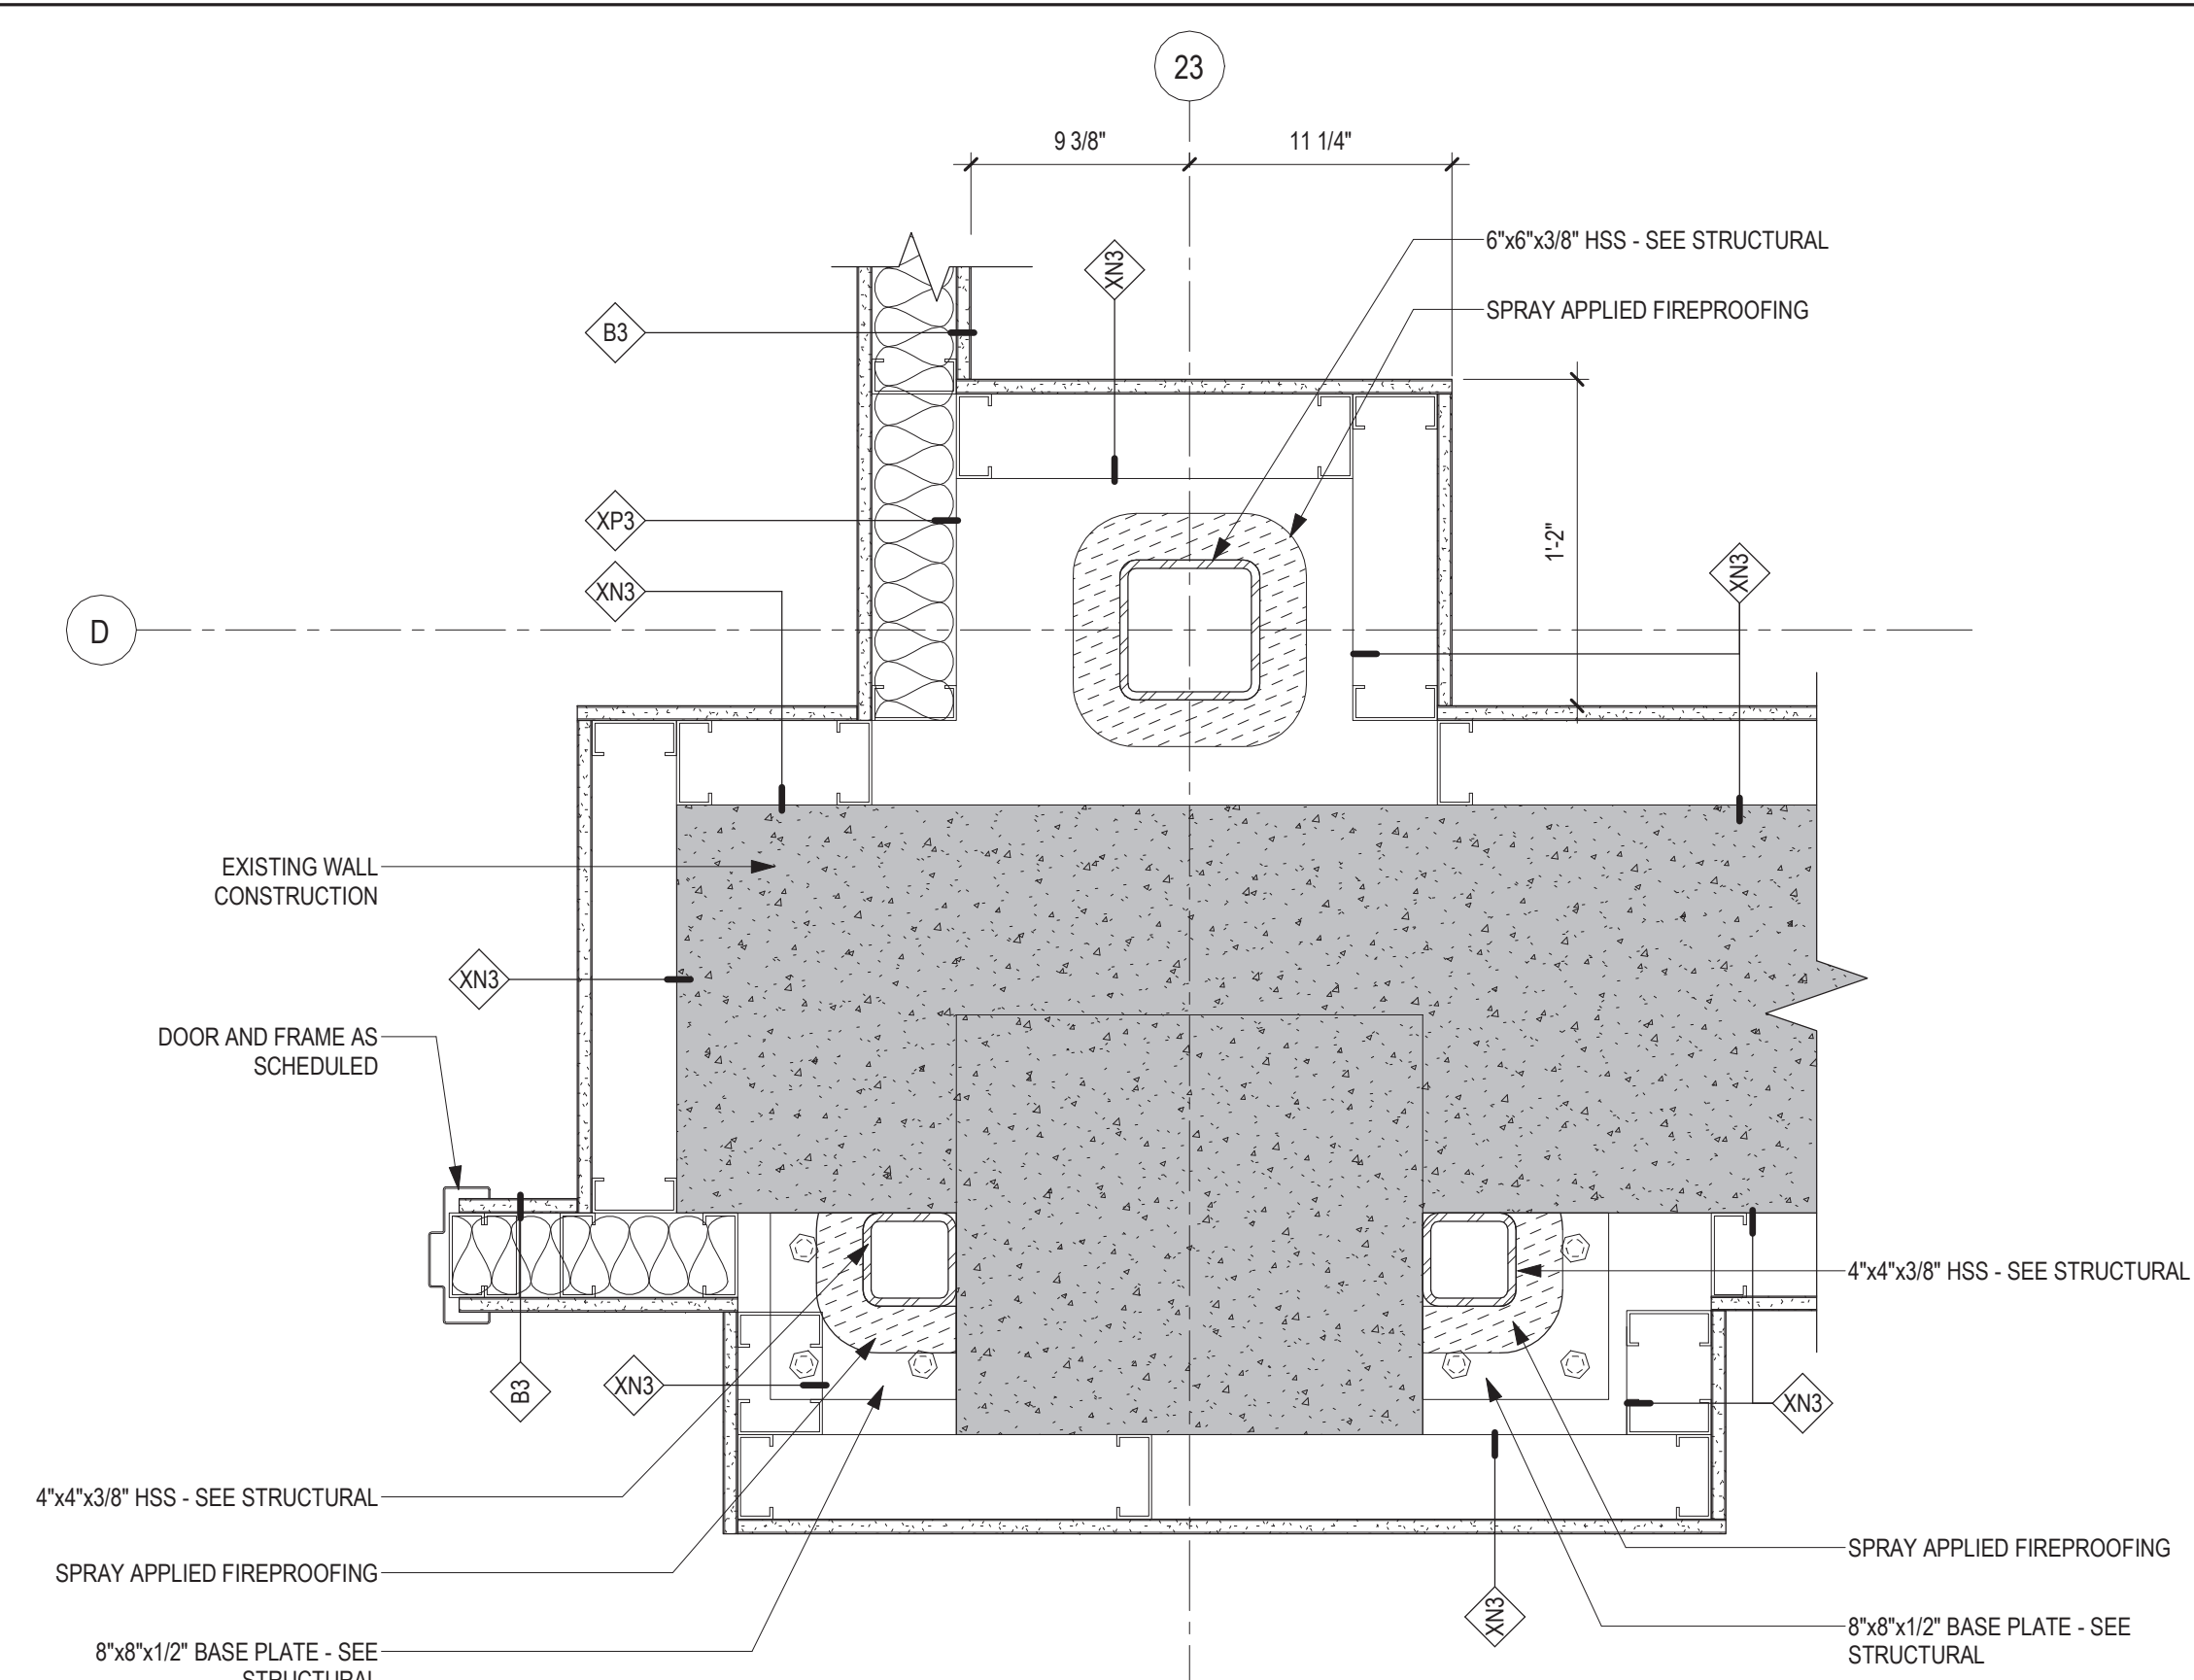


4 PLAN DETAIL - PARTITION @ COLUMN D-23
1 1/2" = 1'-0"

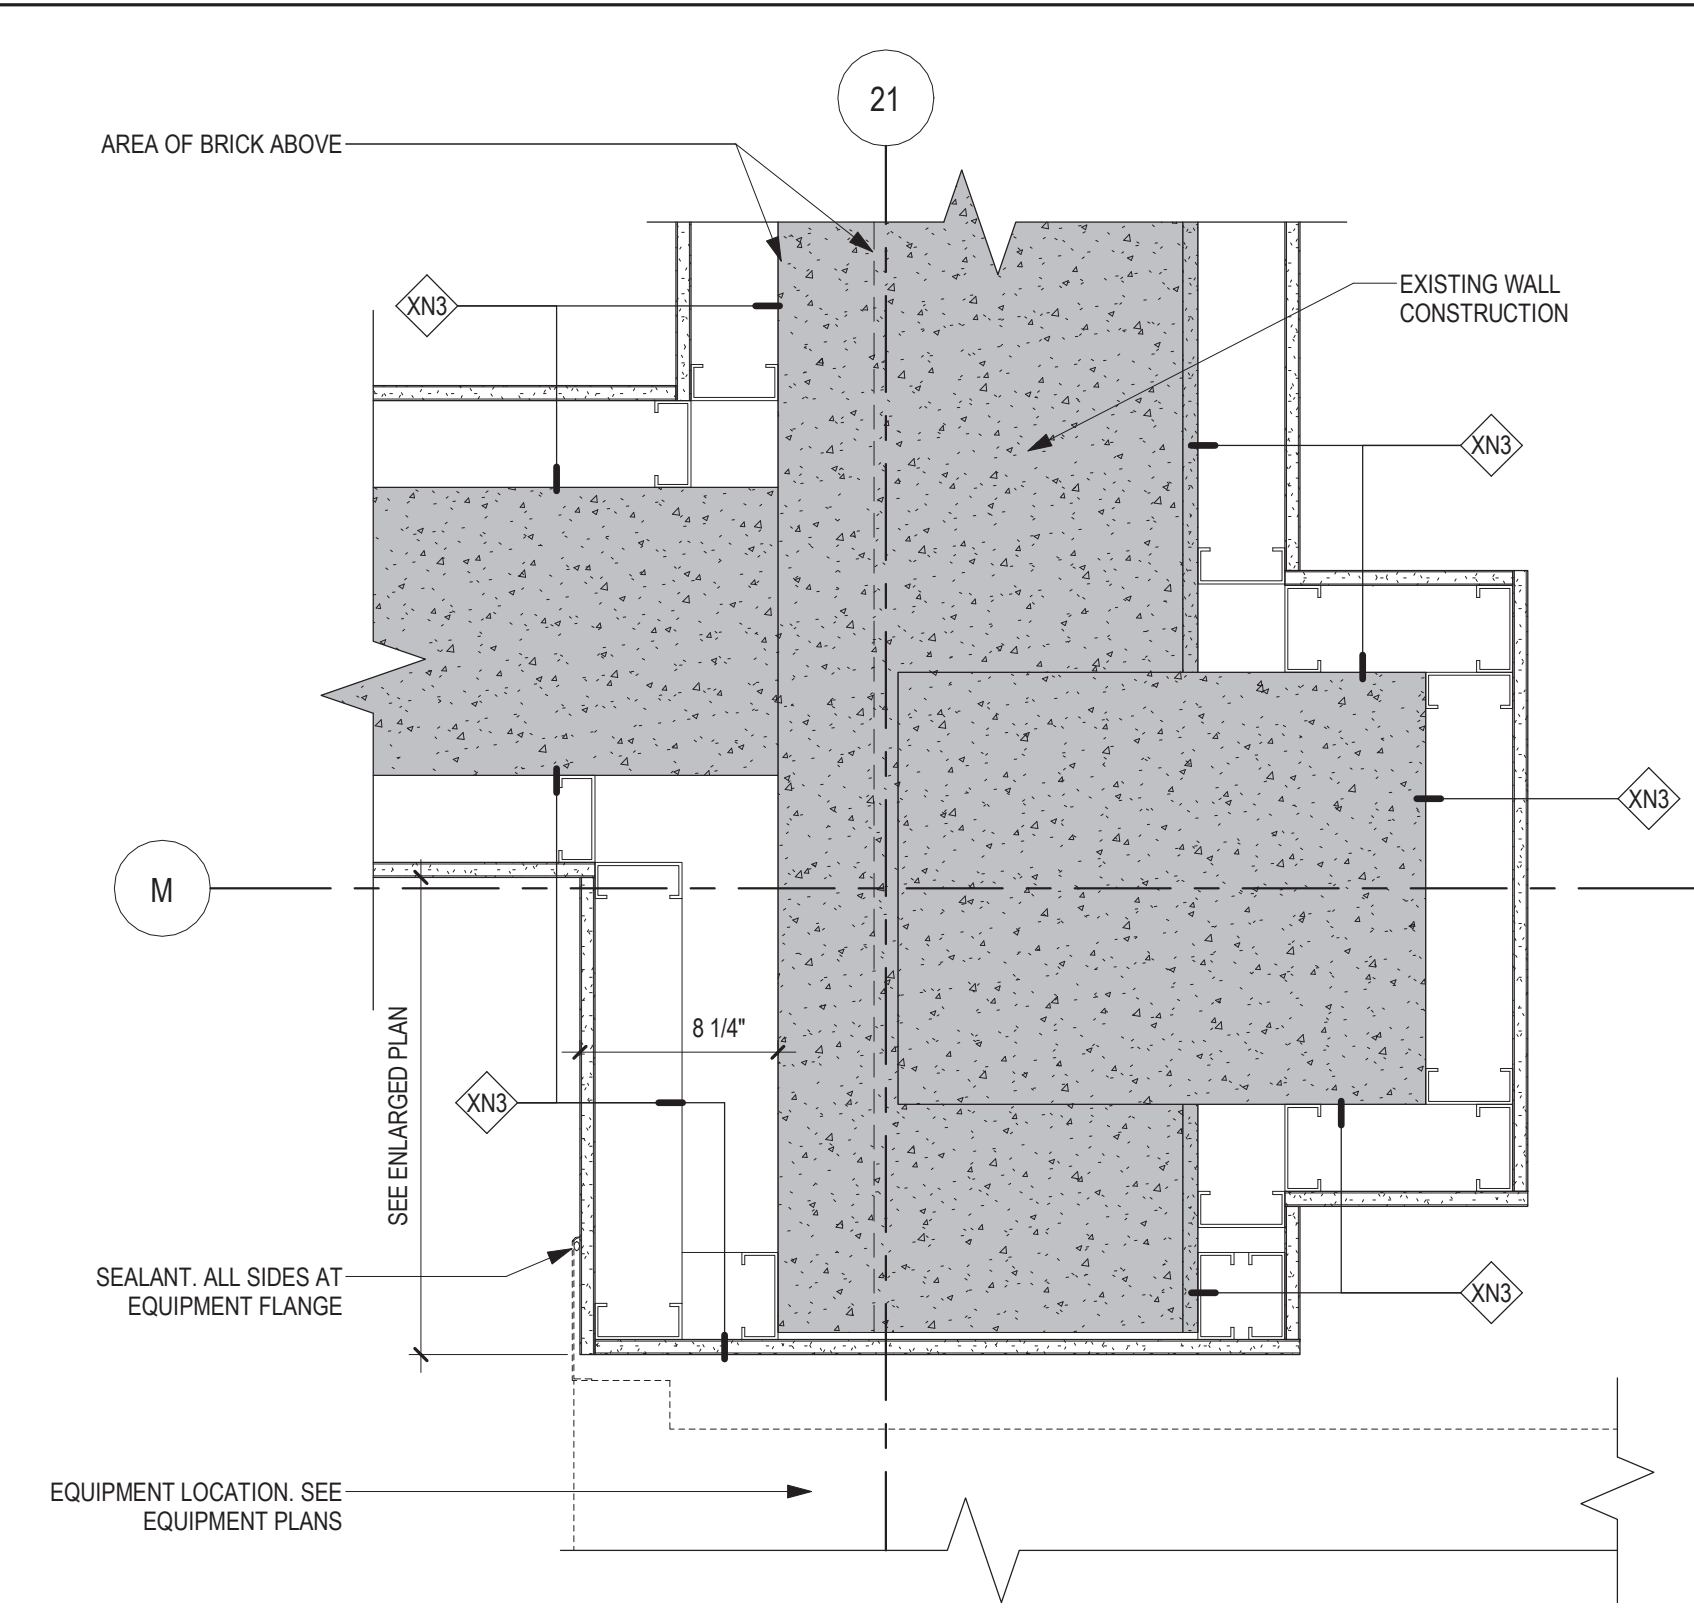


3 PLAN DETAIL - PARTITION OPENING AT STEAM STERILIZER
1 1/2" = 1'-0"

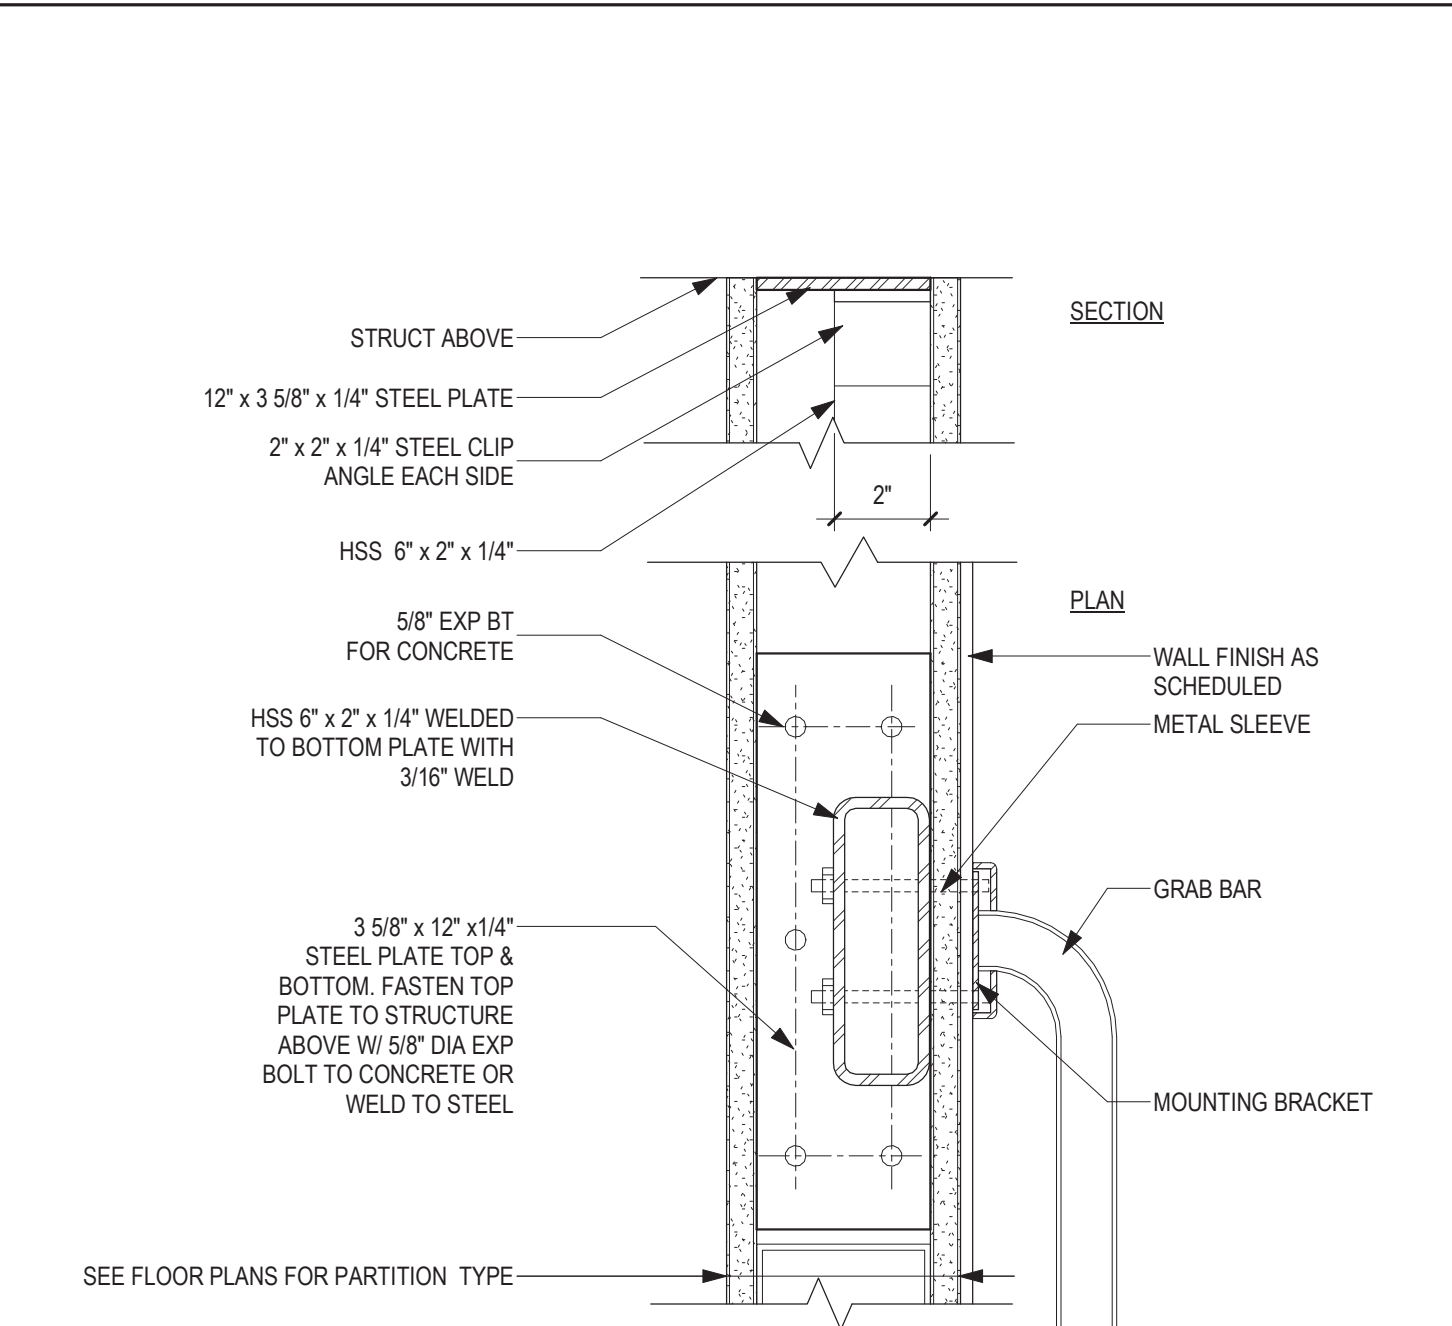


2 DETAIL - GRAB BAR SUPPORT - STEEL
3" = 1'-0"

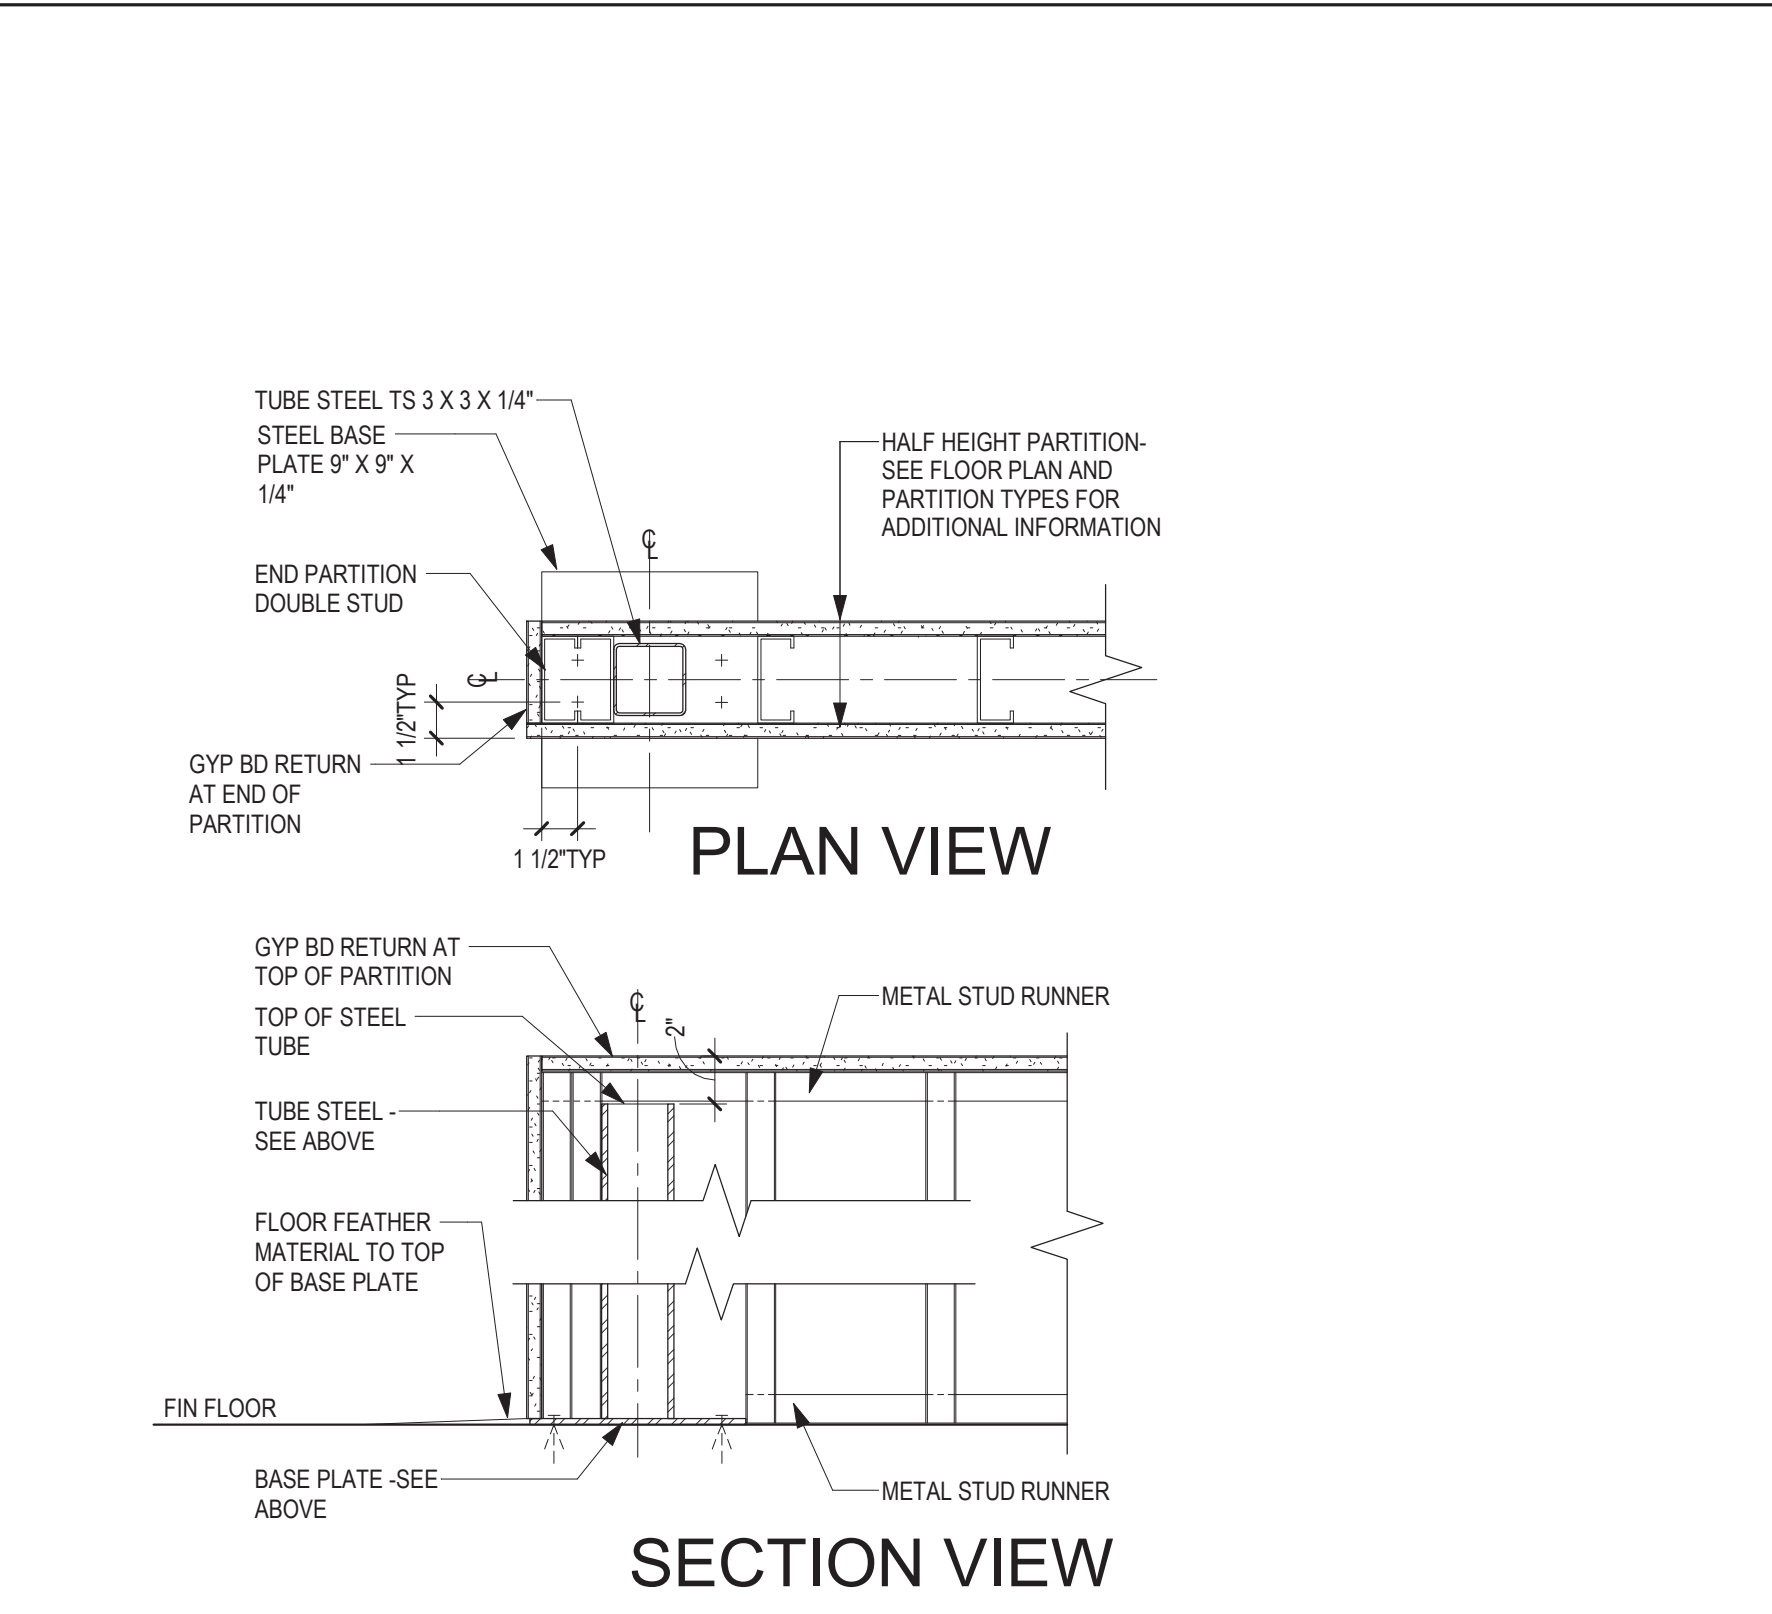


1 INTERIOR DETAIL - PARTIAL HEIGHT PARTITION-STEEL SUPPORT
1 1/2" = 1'-0"

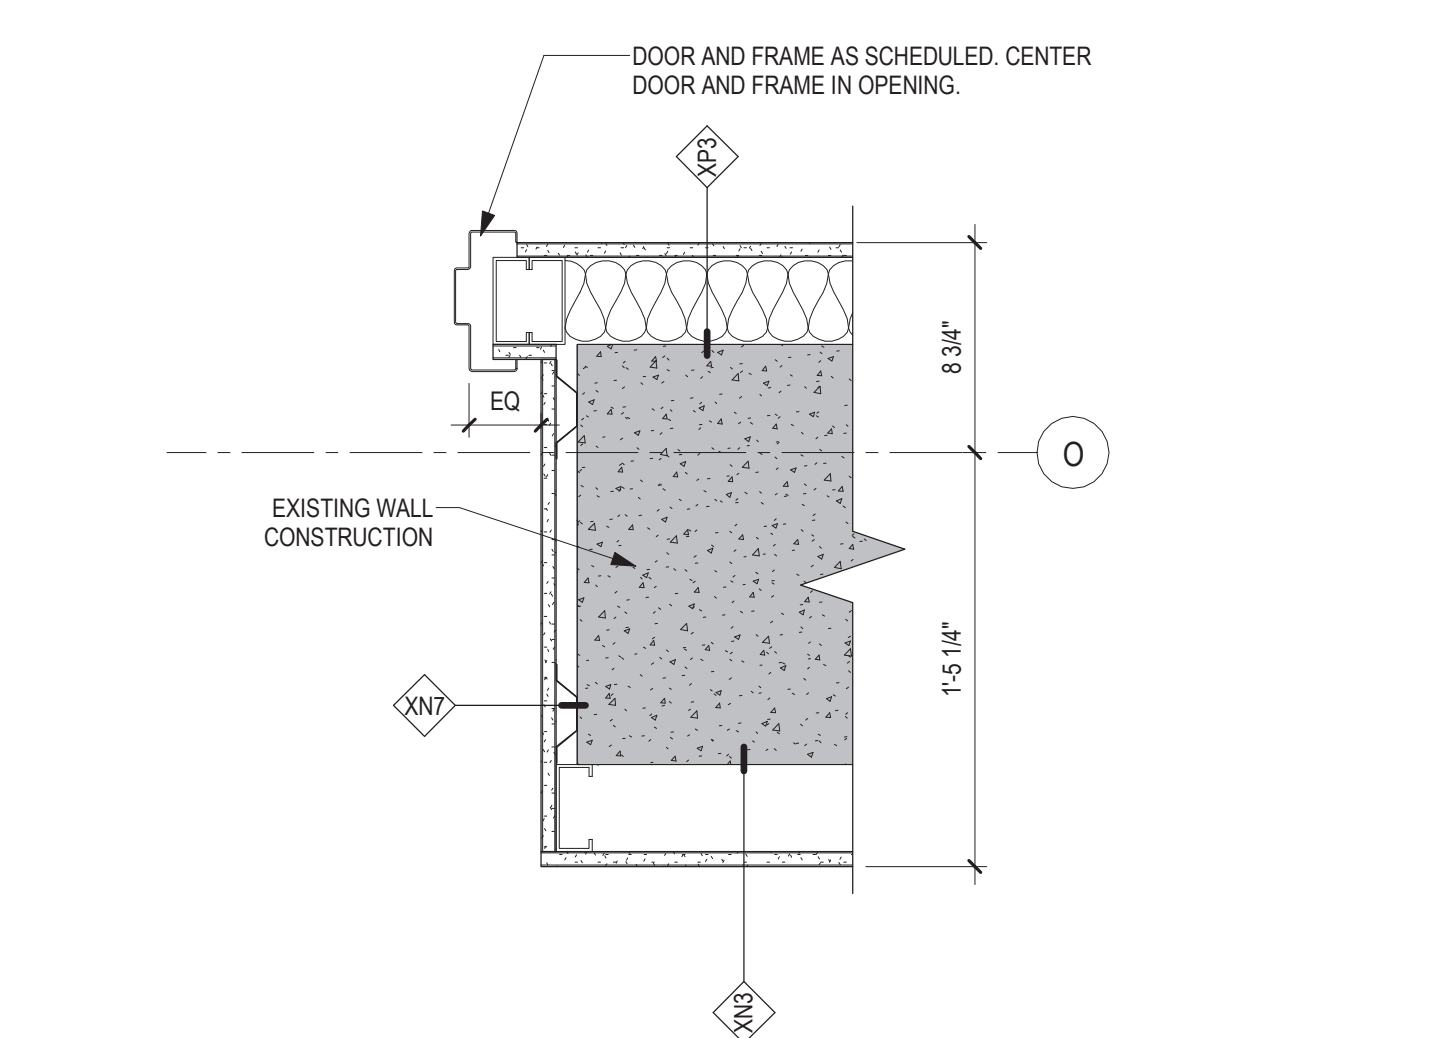


8 PLAN DETAIL - PARTITION AND DOOR JAMB AT DOOR H20AA
1 1/2" = 1'-0"

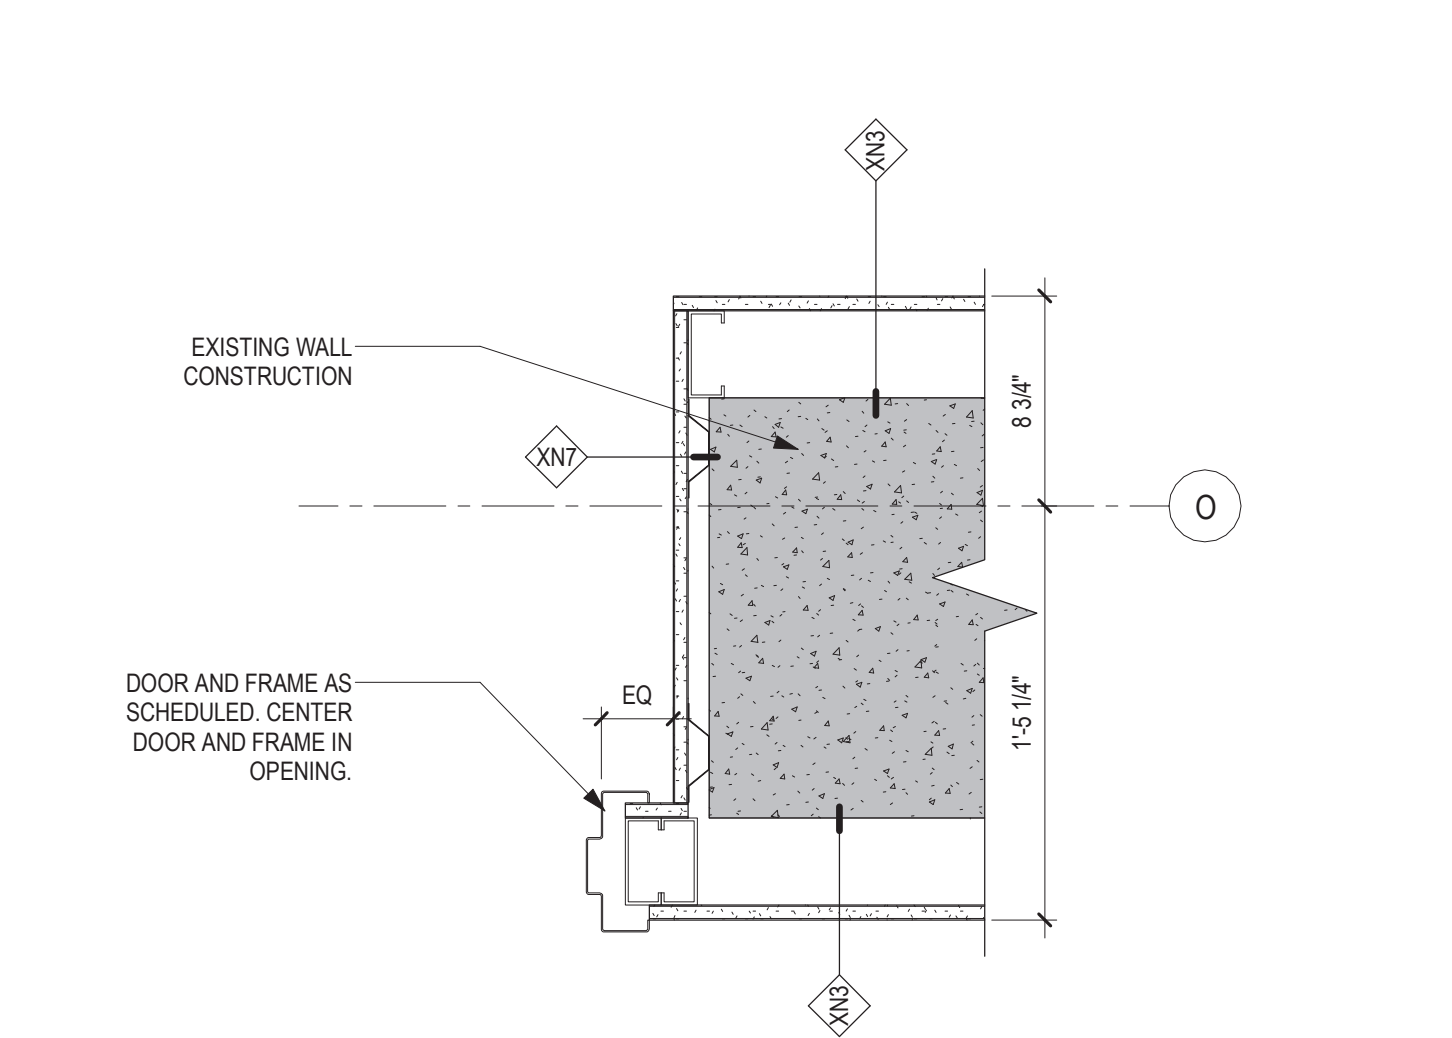


7 PLAN DETAIL - PARTITION AND DOOR JAMB AT DOOR H26B
1 1/2" = 1'-0"

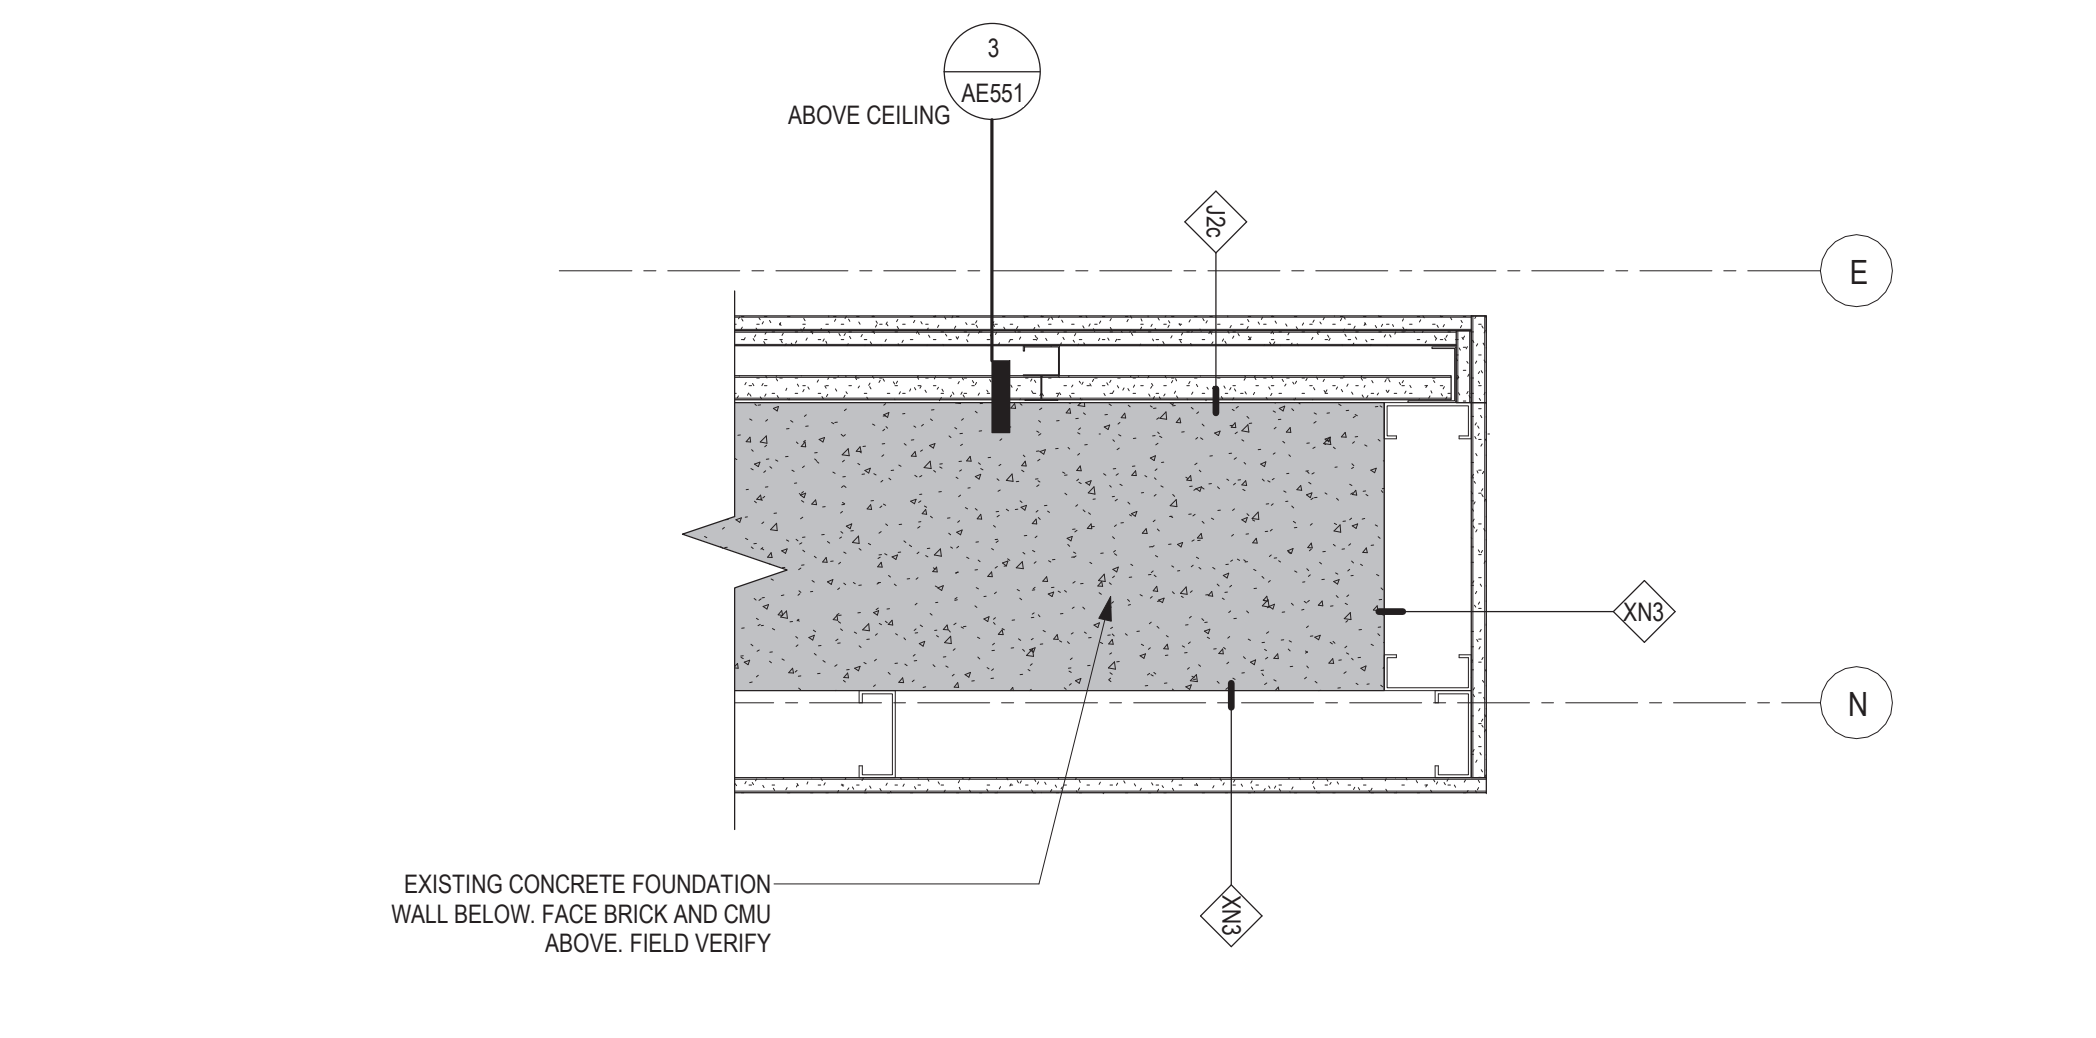


6 PLAN DETAIL - PARTITION AT OPENING IN STAIR TOWER FOUNDATION - SOUTH
1 1/2" = 1'-0"

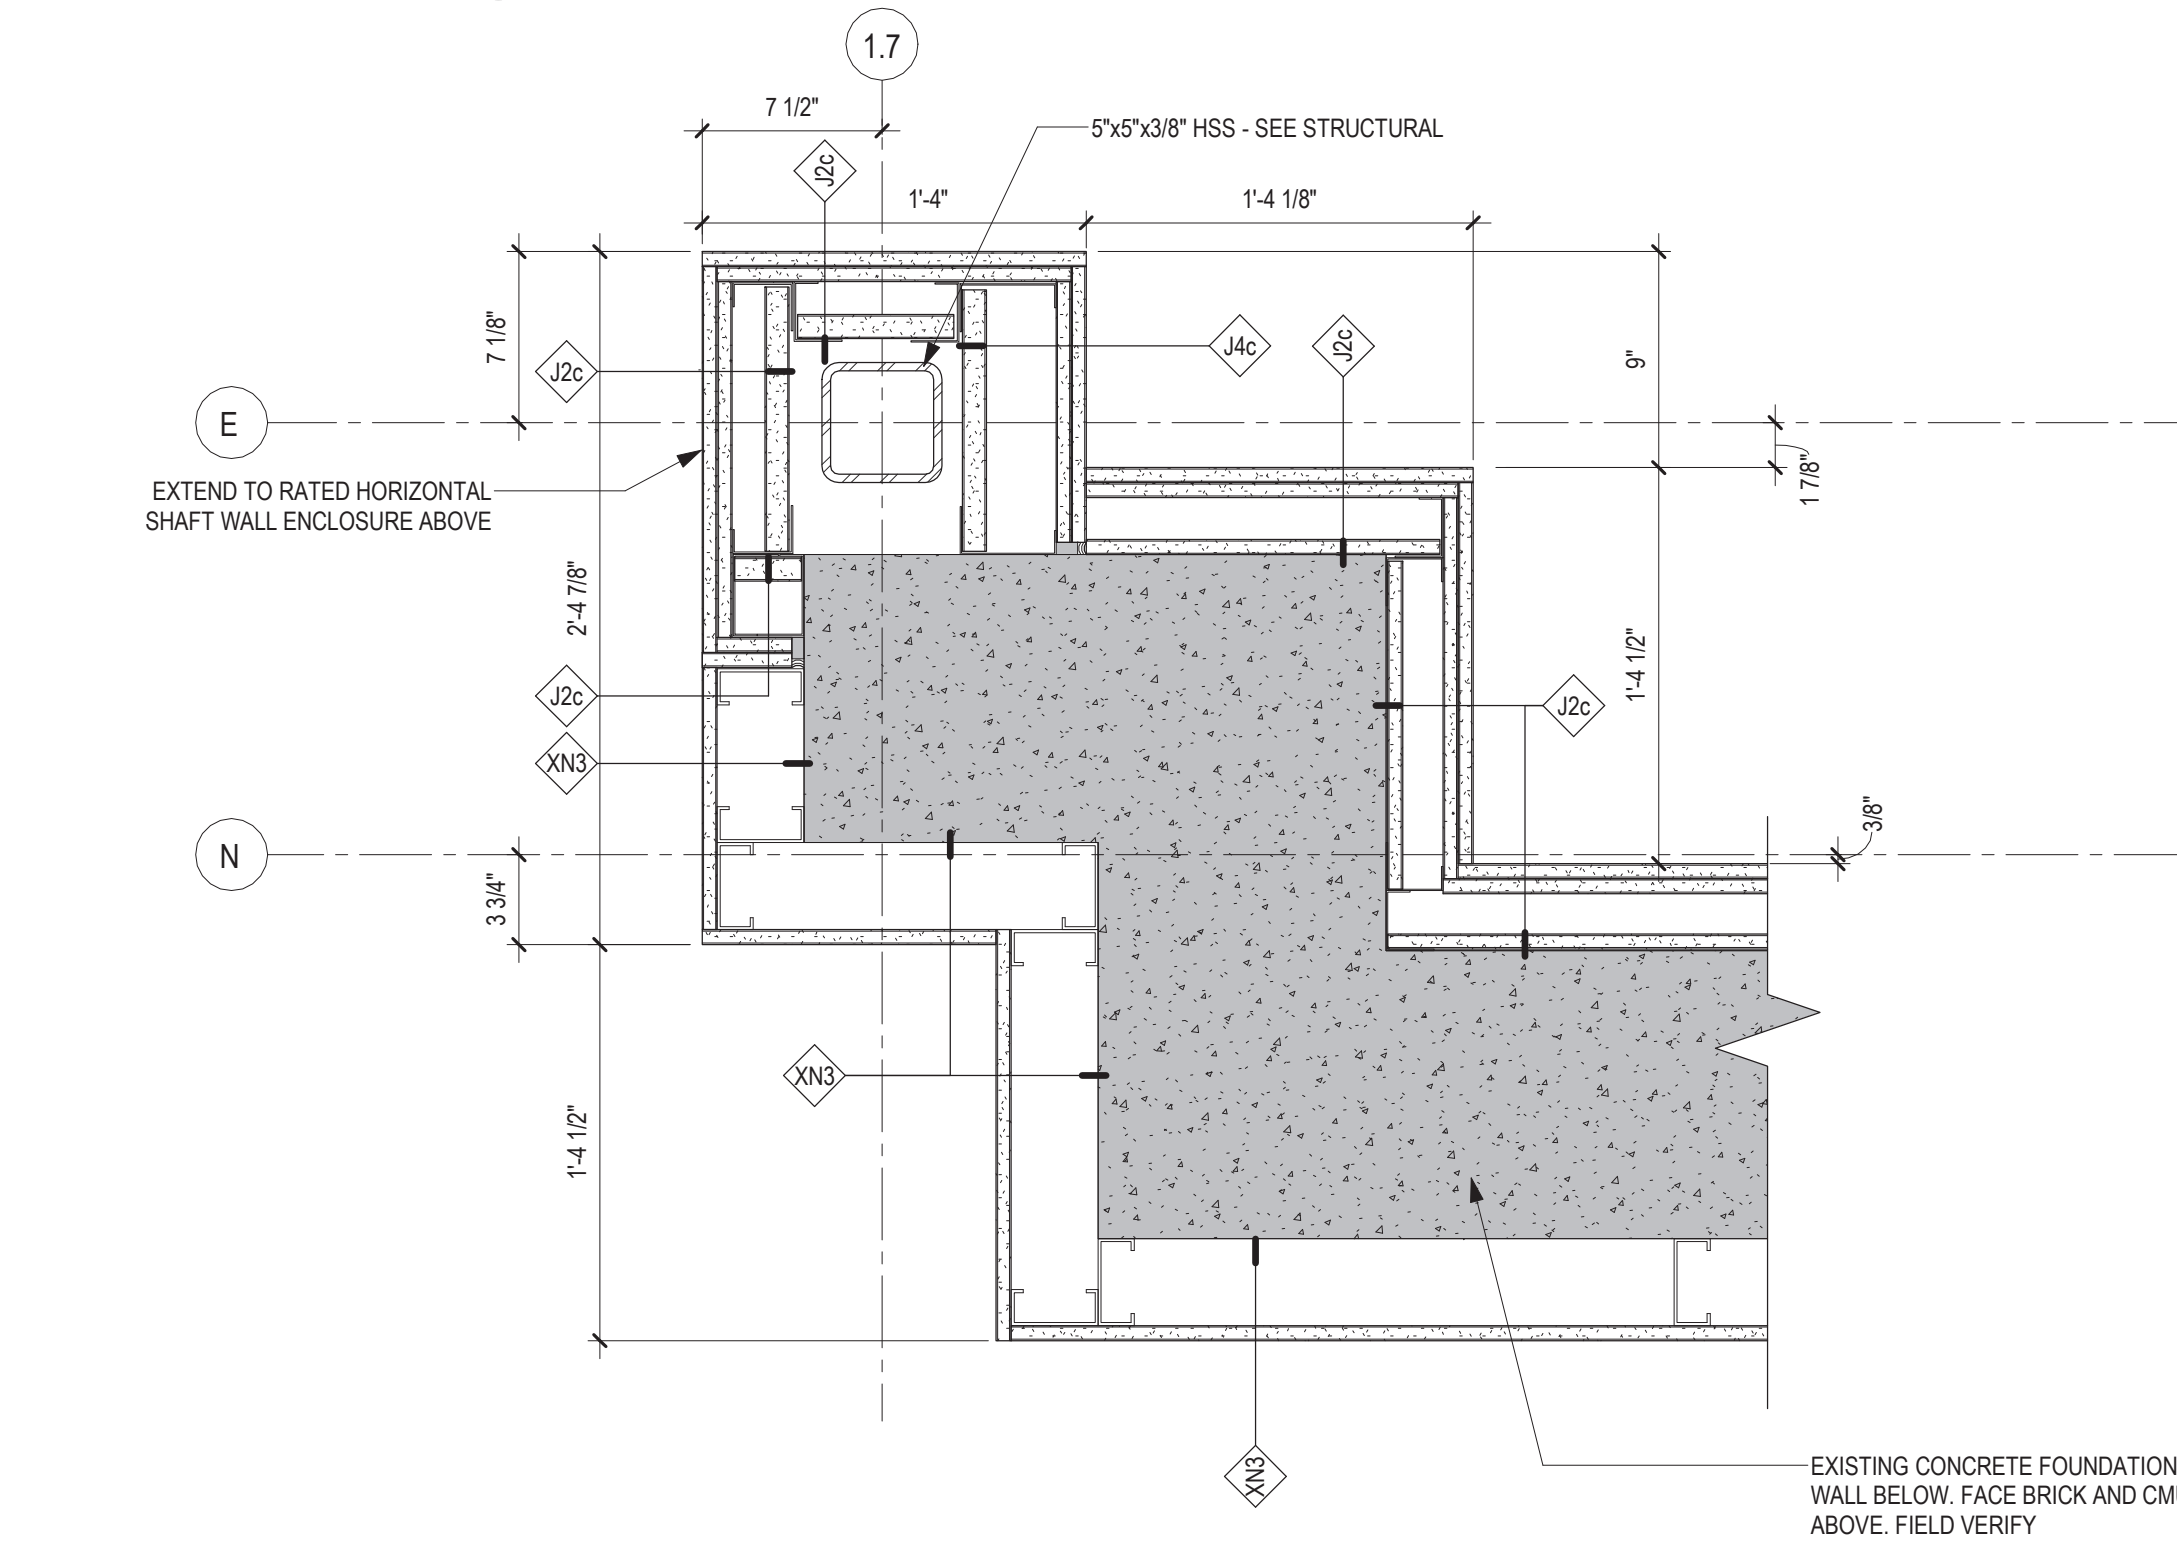


5 PLAN DETAIL - PARTITION AT OPENING IN STAIR TOWER FOUNDATION - NORTH
1 1/2" = 1'-0"

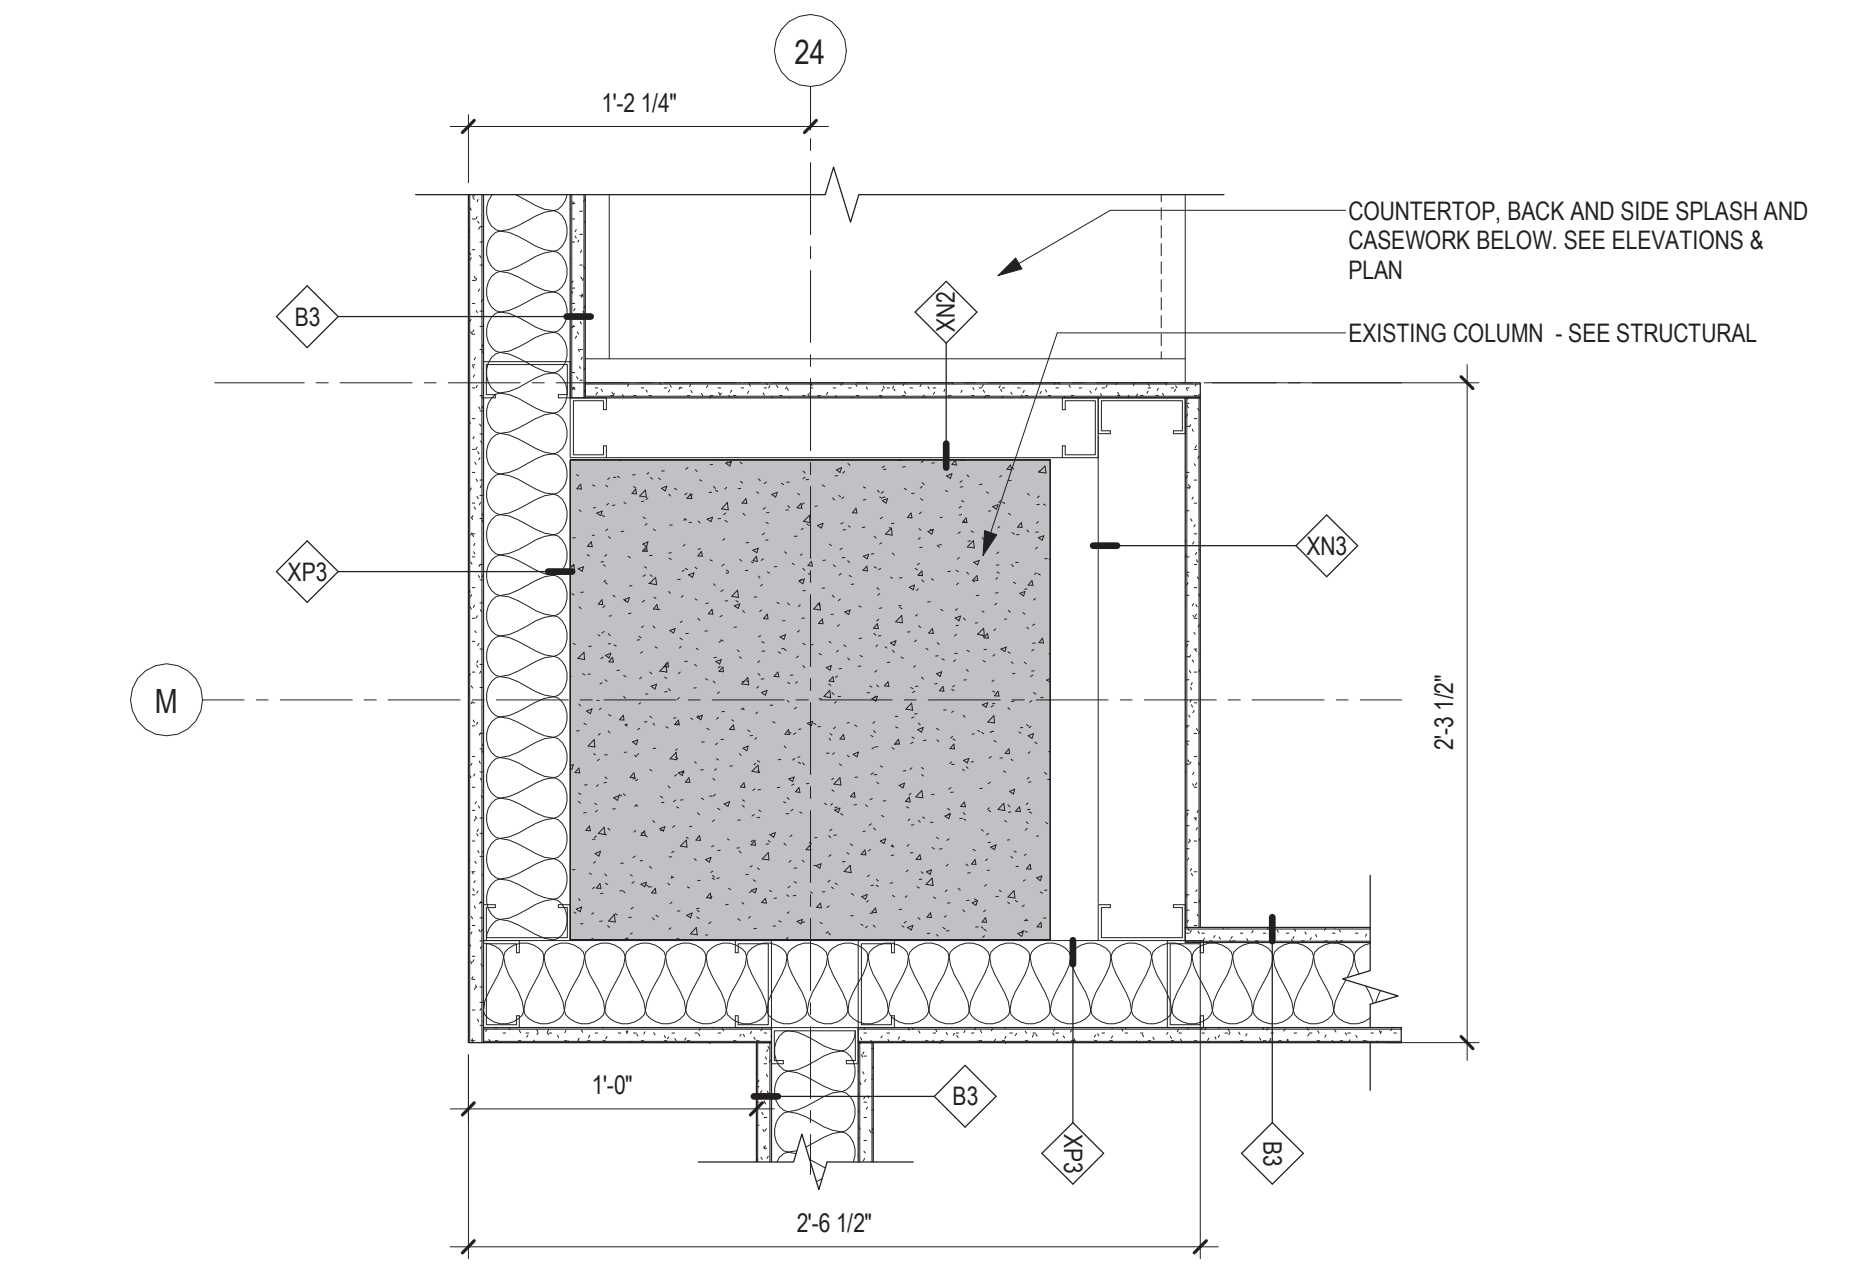

11 PLAN DETAIL - PARTITION @ COLUMN M-24
1 1/2" = 1'-0"

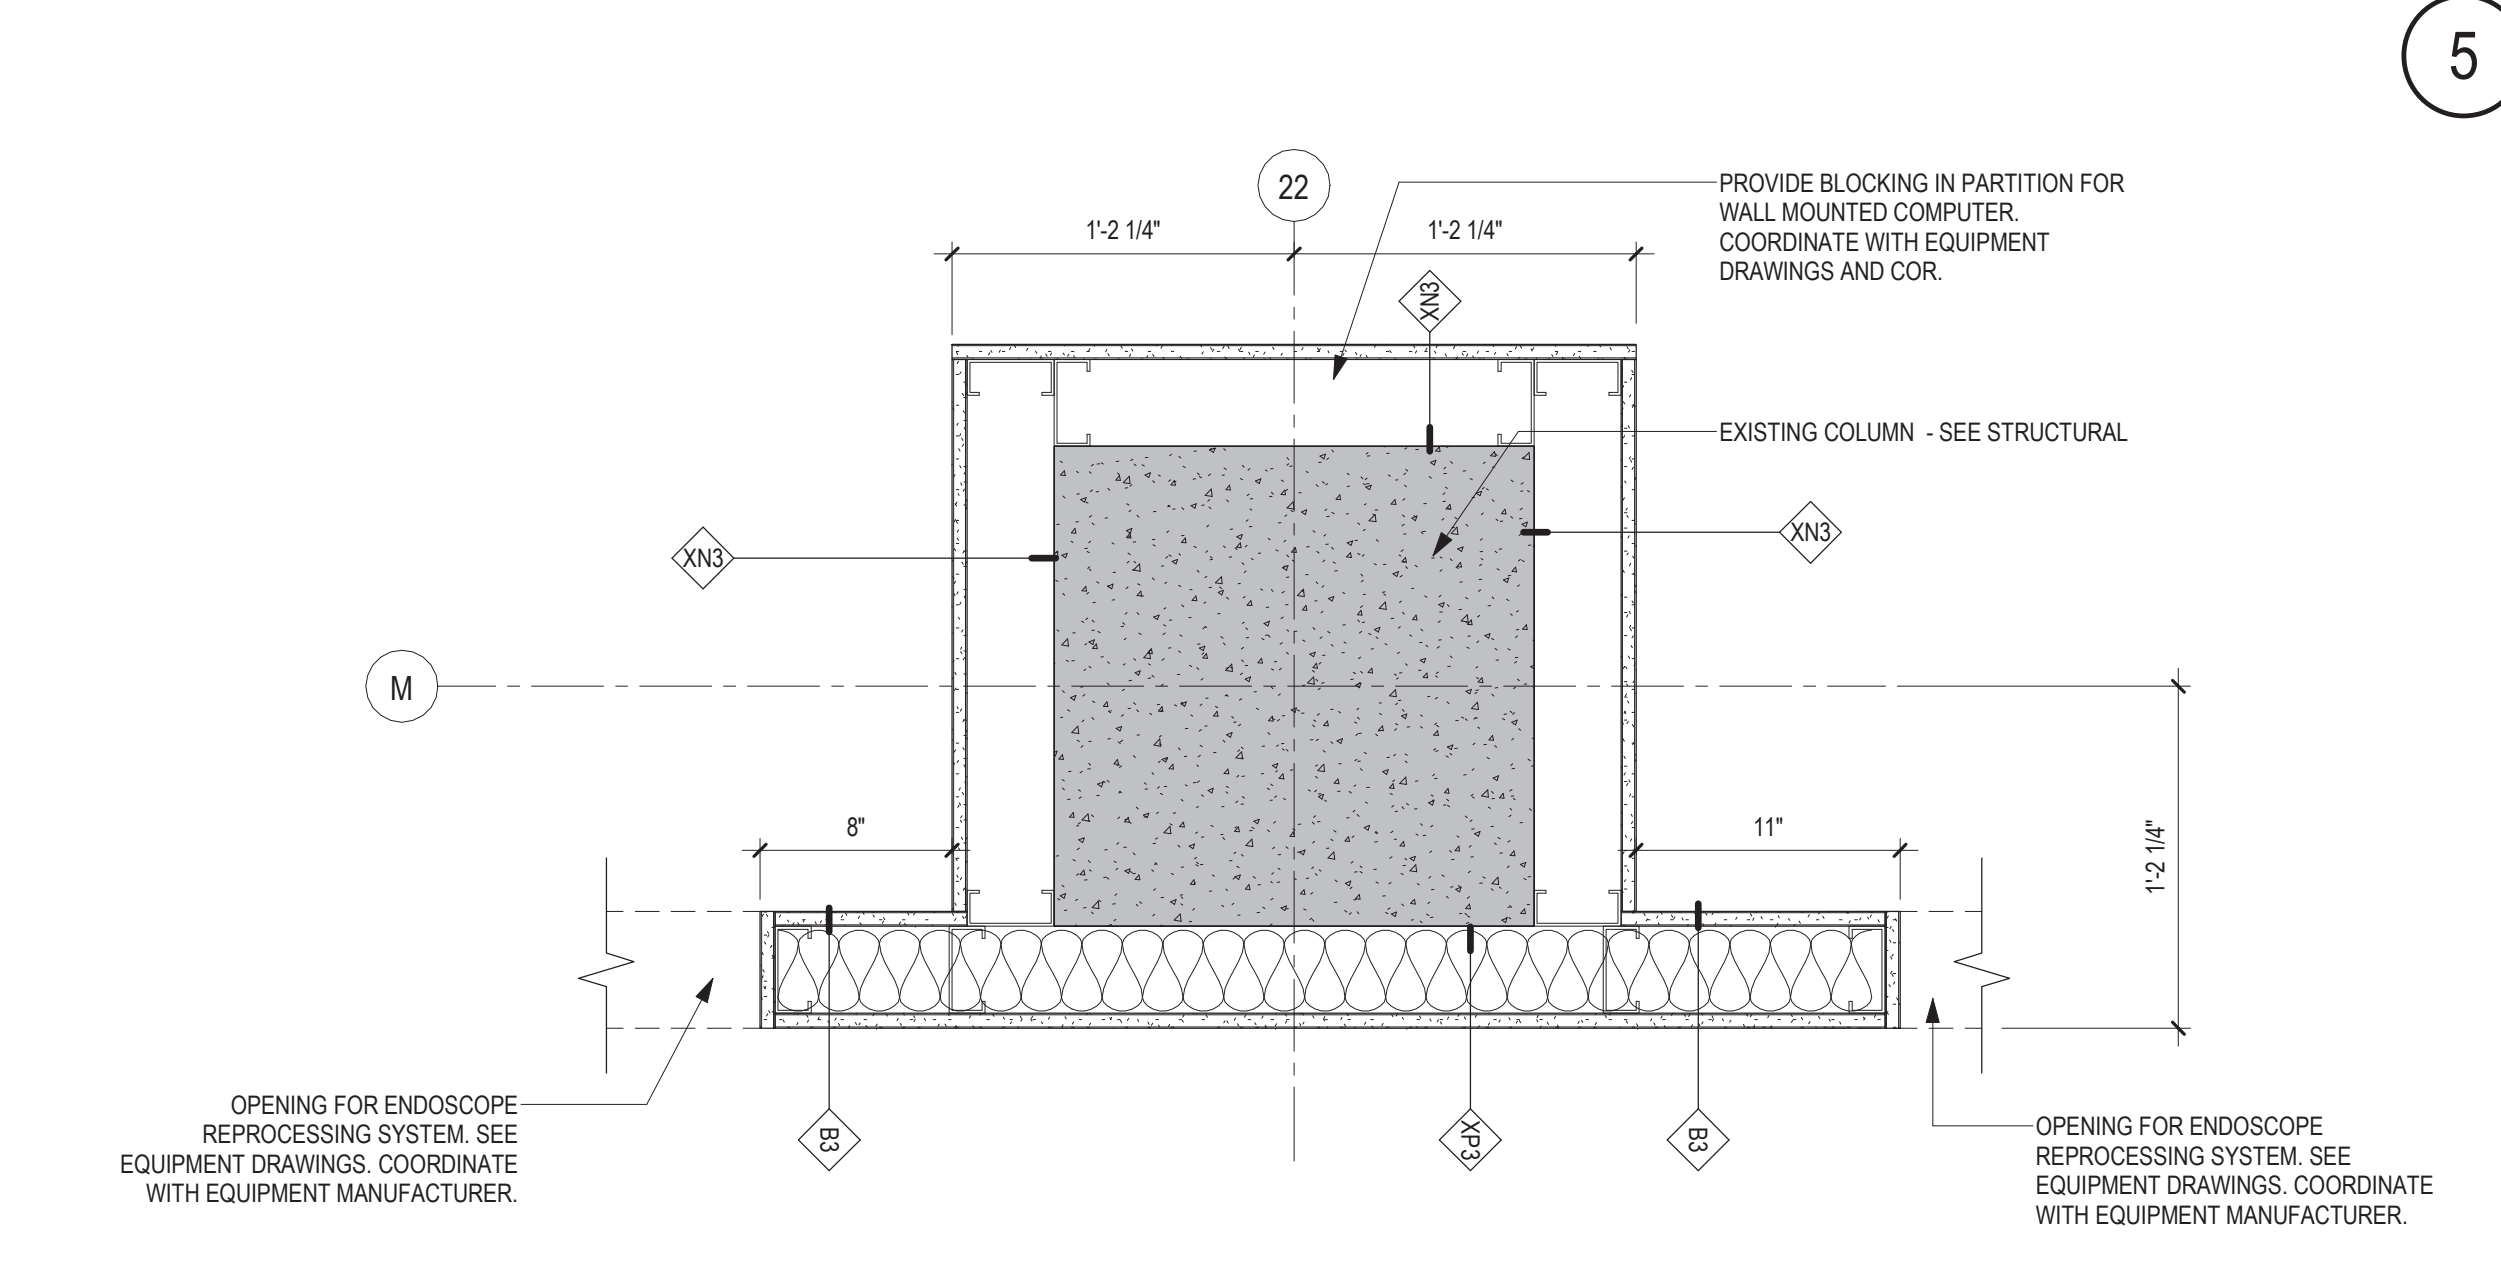

10 PLAN DETAIL - PARTITION @ COLUMN M-23
1 1/2" = 1'-0"

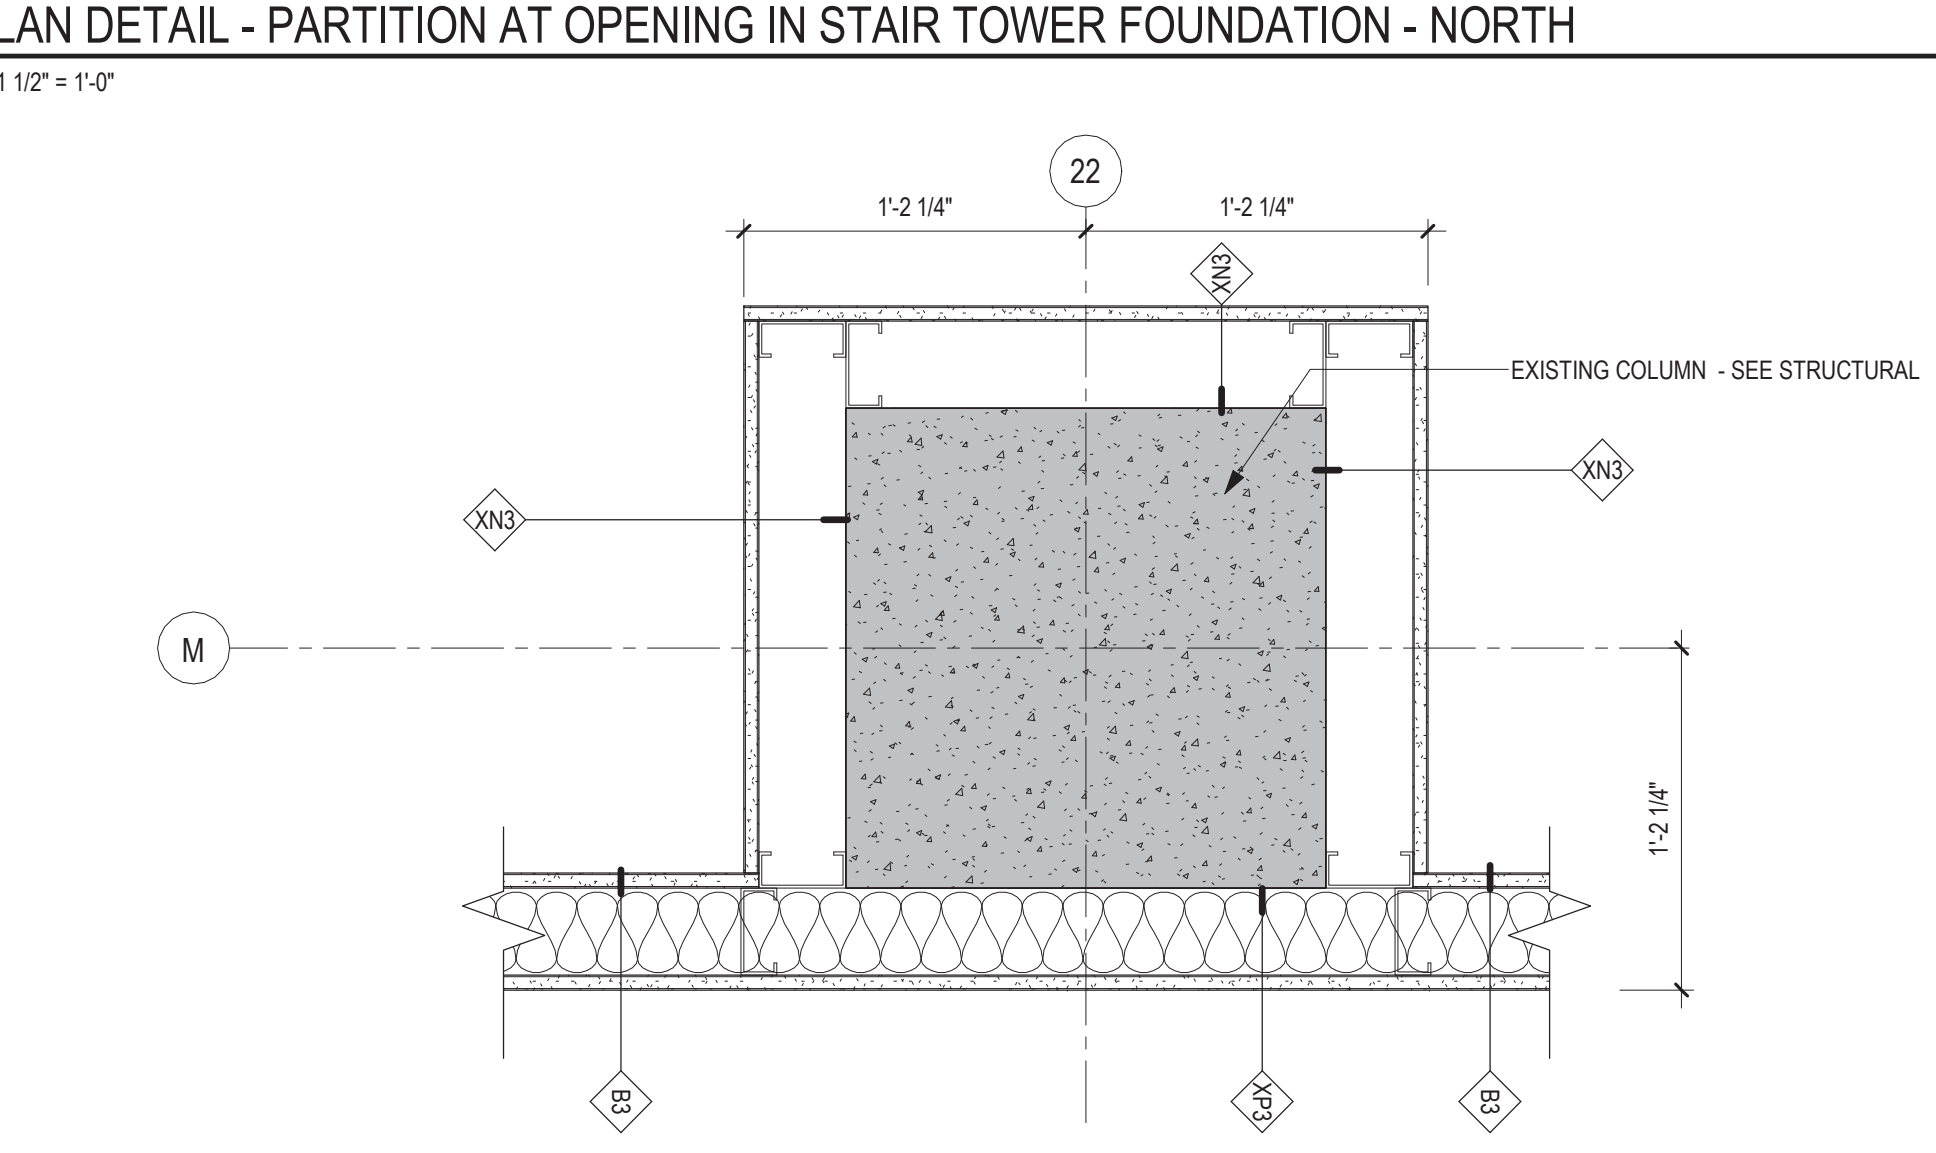

9 PLAN DETAIL - PARTITION @ COLUMN M-22
1 1/2" = 1'-0"

--	--	
A


B

C

D

E

F

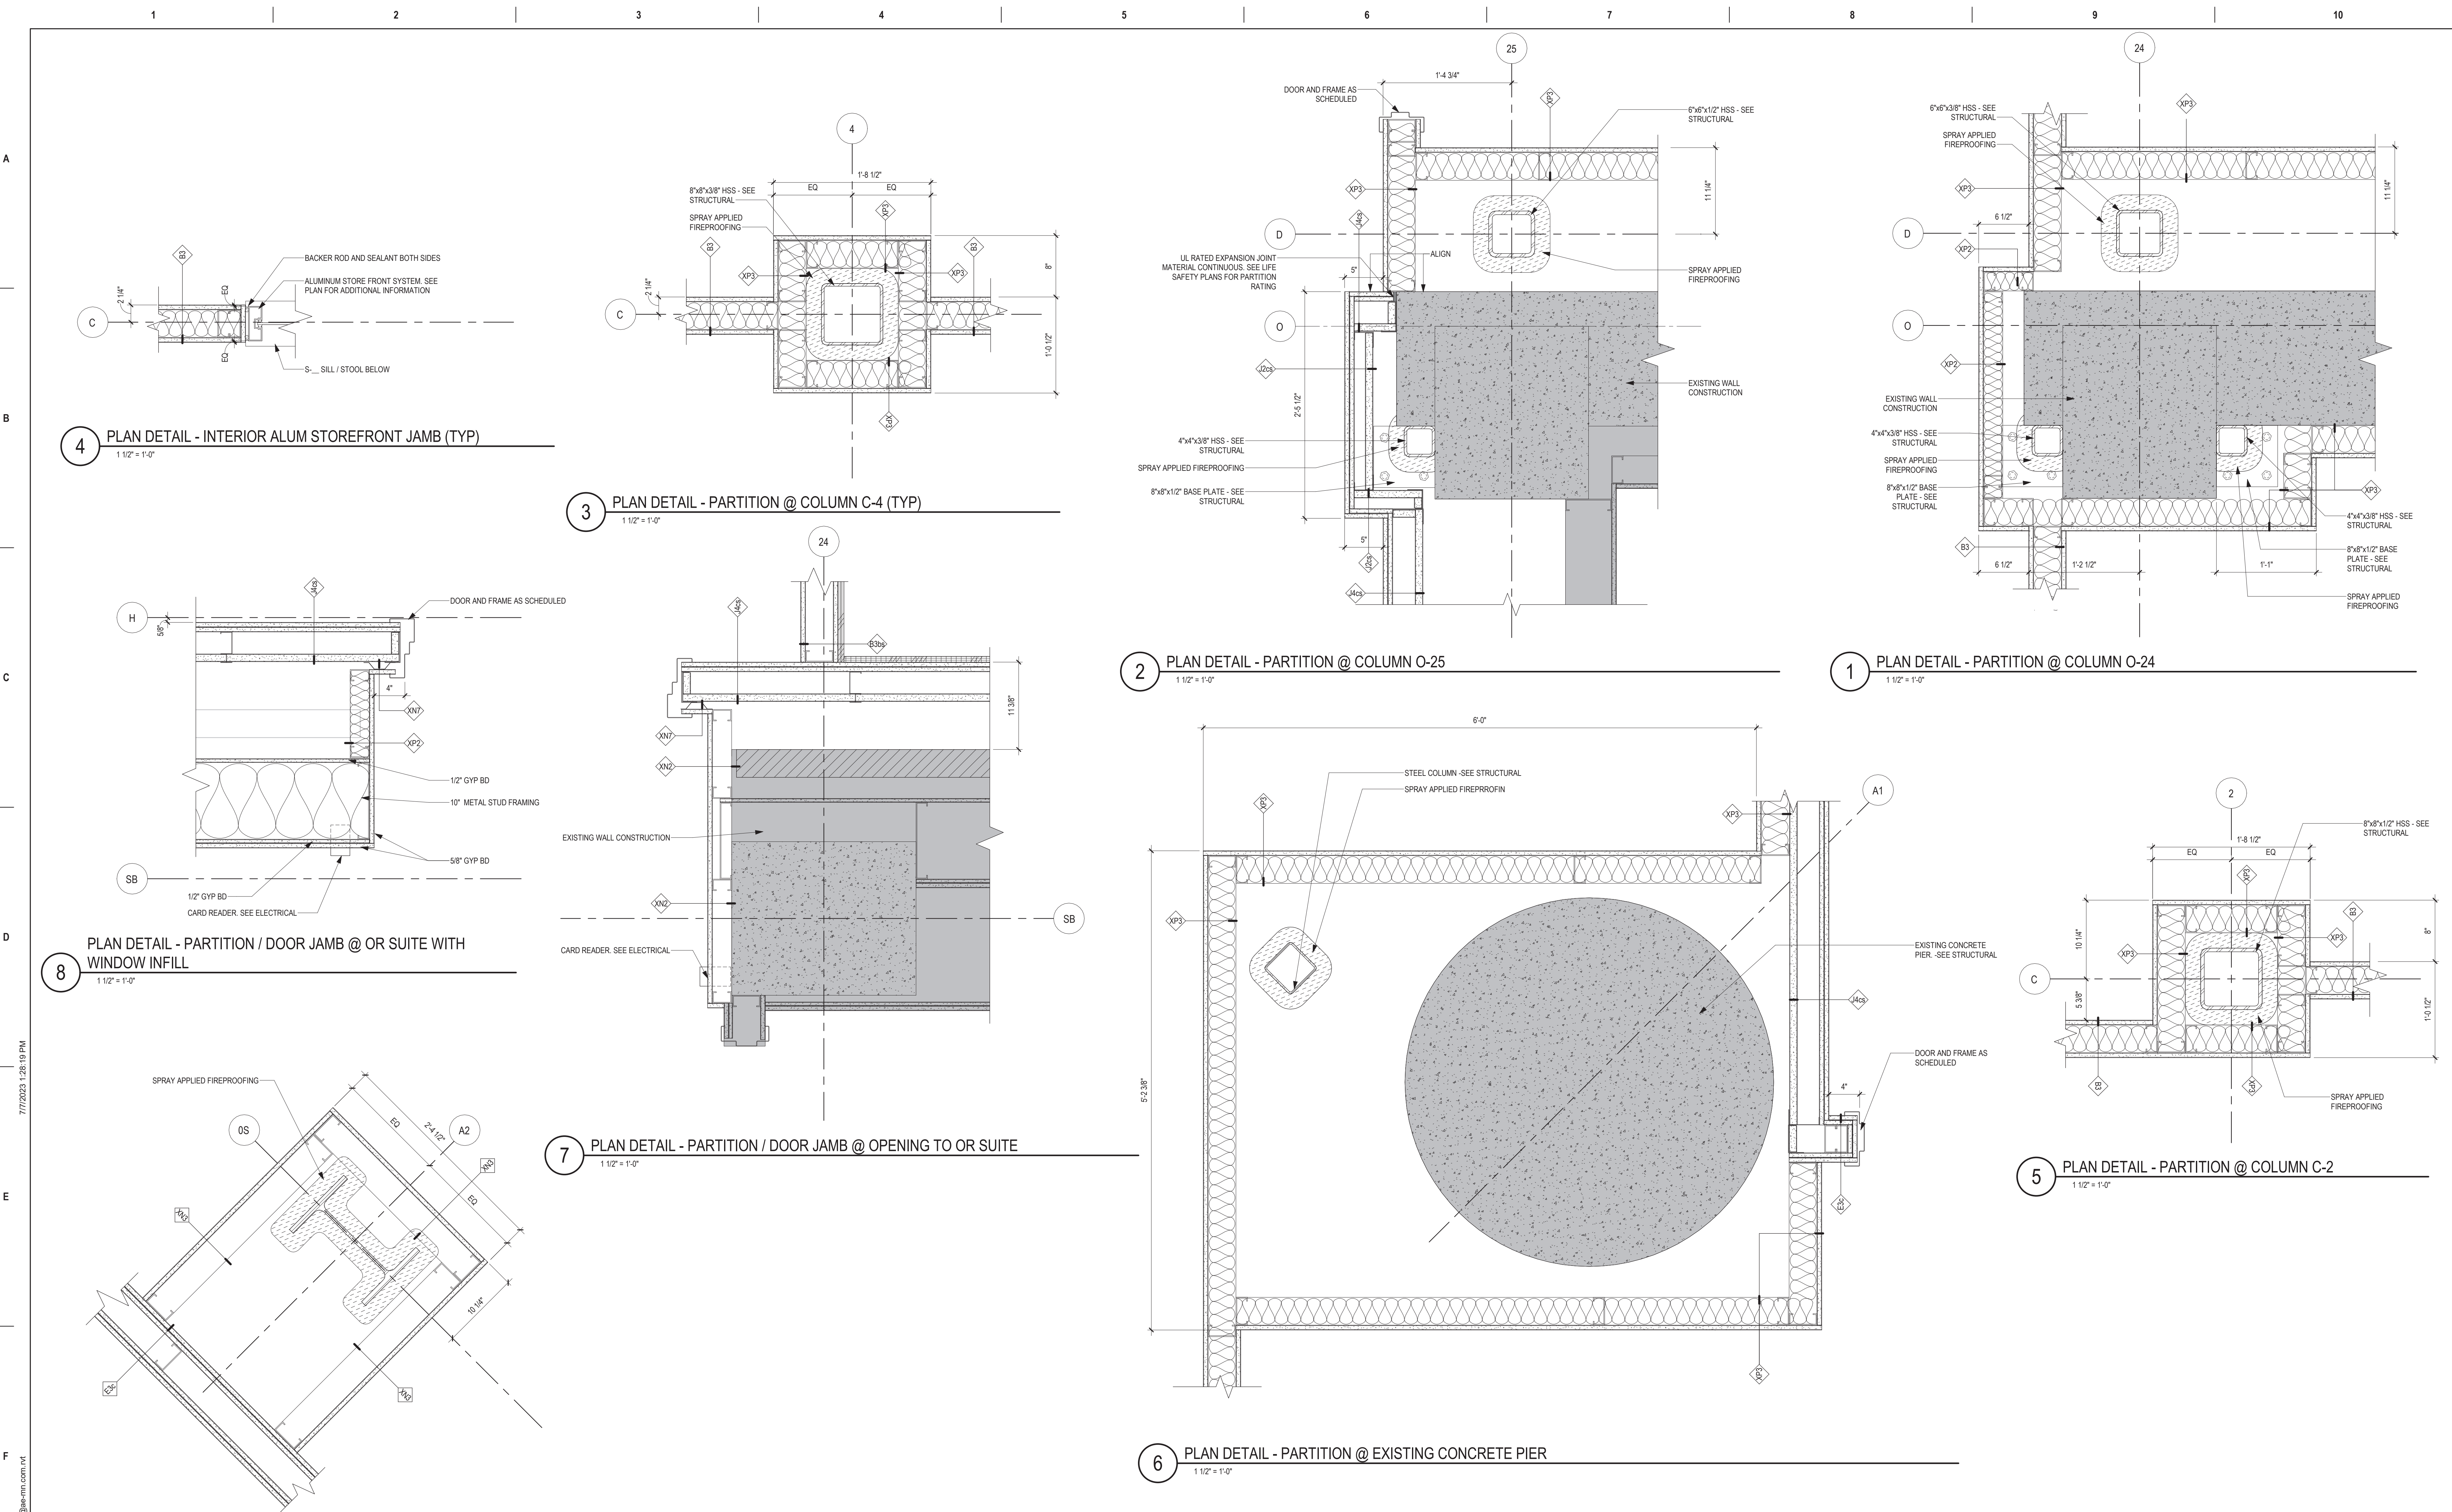

Revisions:

Date:

CONSULTANT

IMEG

ARCHITECT/ENGINEER OF RECORD

ANDERSON

13605 1st Ave. N. #100 Plymouth, MN 55441
P 763.412.4000 | F 763.412.4090 | ae-mn.com
Anderson Engineering of Minnesota, LLC | Proj # 16684

STAMP

Professional Engineer
State of Minnesota
No. 1000000000
Name: THOMAS A. OLESAR
City: SOUTH DAKOTA

DATE: 08/04/2022
License # 9335

Office of Construction and Facilities Management

U.S. Department of Veterans Affairs

Drawing Title

INTERIOR PLAN DETAILS

Approved:

Phase

BID DOCUMENTS

FULLY SPRINKLERED

Project Title

CONSTRUCT NEW SPS

Location
Sioux Falls, SD.

Issue Date
08/04/2022

Checked
Checker

Drawn
Author

Project Number

438-460

Building Number

5

Drawing Number

AE541

VA FORM 08 - 6231

1

2

3

4

5


6

7


8

9


10

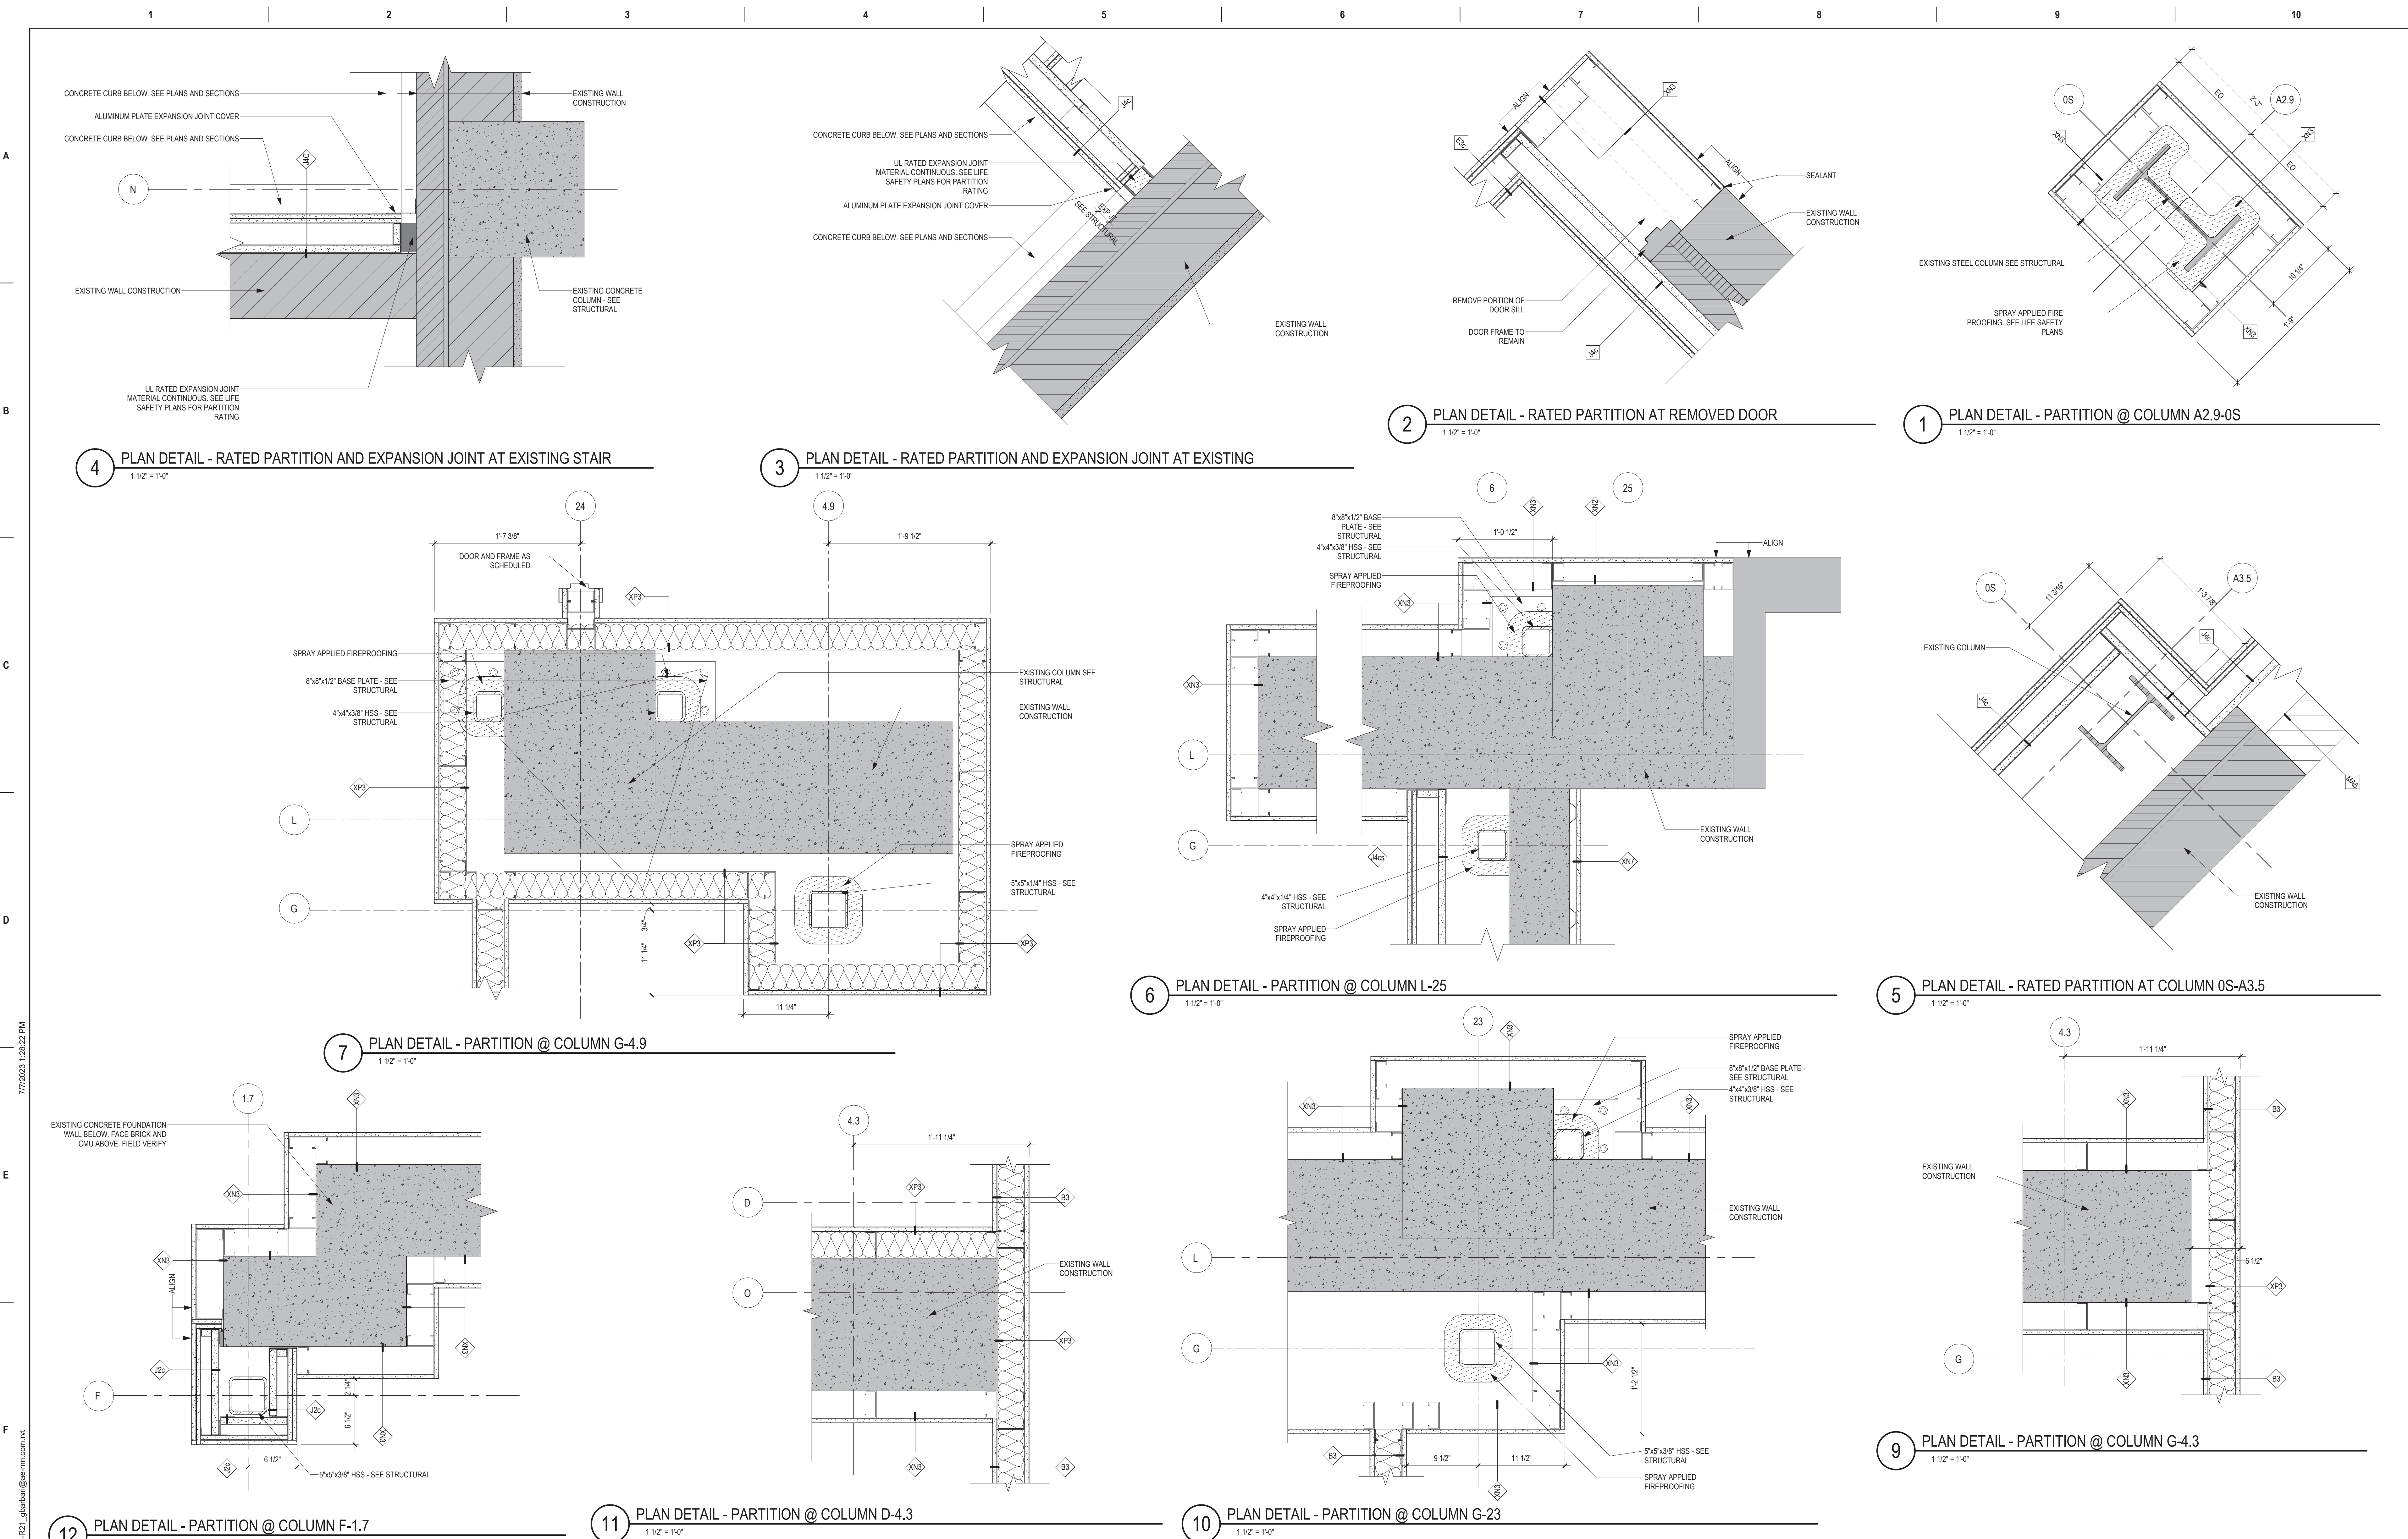


Revisions: <table border="1"><thead><tr><th>NO.</th><th>DESCRIPTION</th><th>DATE</th></tr></thead><tbody><tr><td> </td><td> </td><td> </td></tr><tr><td> </td><td> </td><td> </td></tr><tr><td> </td><td> </td><td> </td></tr><tr><td> </td><td> </td><td> </td></tr><tr><td> </td><td> </td><td> </td></tr><tr><td> </td><td> </td><td> </td></tr><tr><td> </td><td> </td><td> </td></tr><tr><td> </td><td> </td><td> </td></tr><tr><td> </td><td> </td><td> </td></tr></tbody></table>	NO.	DESCRIPTION	DATE																												CONSULTANT	ARCHITECT/ENGINEER OF RECORD 13605 1st Ave. N. #100 Plymouth, MN 55441 P 763.412.4000 F 763.412.4090 ae-mn.com Anderson Engineering of Minnesota, LLC Proj # 16684	STAMP DATE: 08/04/2022 License # 9335	Office of Construction and Facilities Management U.S. Department of Veterans Affairs	Drawing Title INTERIOR PLAN DETAILS Approved:	Phase BID DOCUMENTS FULLY SPRINKLERED	Project Title CONSTRUCT NEW SPS Location Sioux Falls, SD. Issue Date 08/04/2022 Checked Checker Drawn Author	Project Number 438-460 Building Number 5 Drawing Number AE542
	NO.	DESCRIPTION	DATE																																			

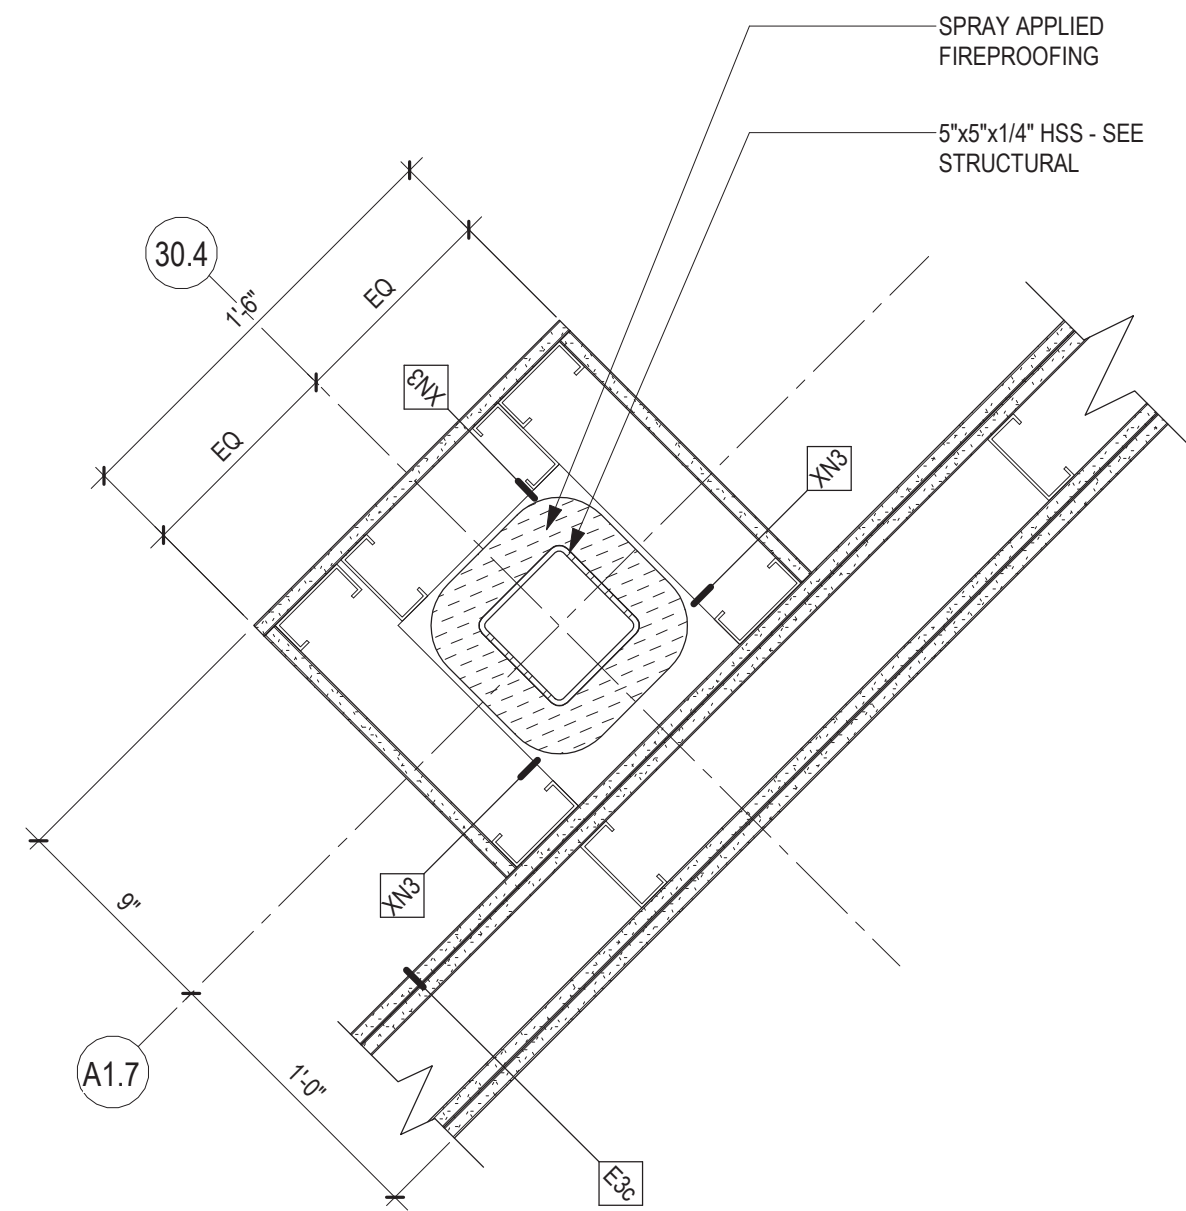


4 PLAN DETAIL - PARTITION @ COLUMN A1.7 - 30.4
1 1/2" = 1'-0"

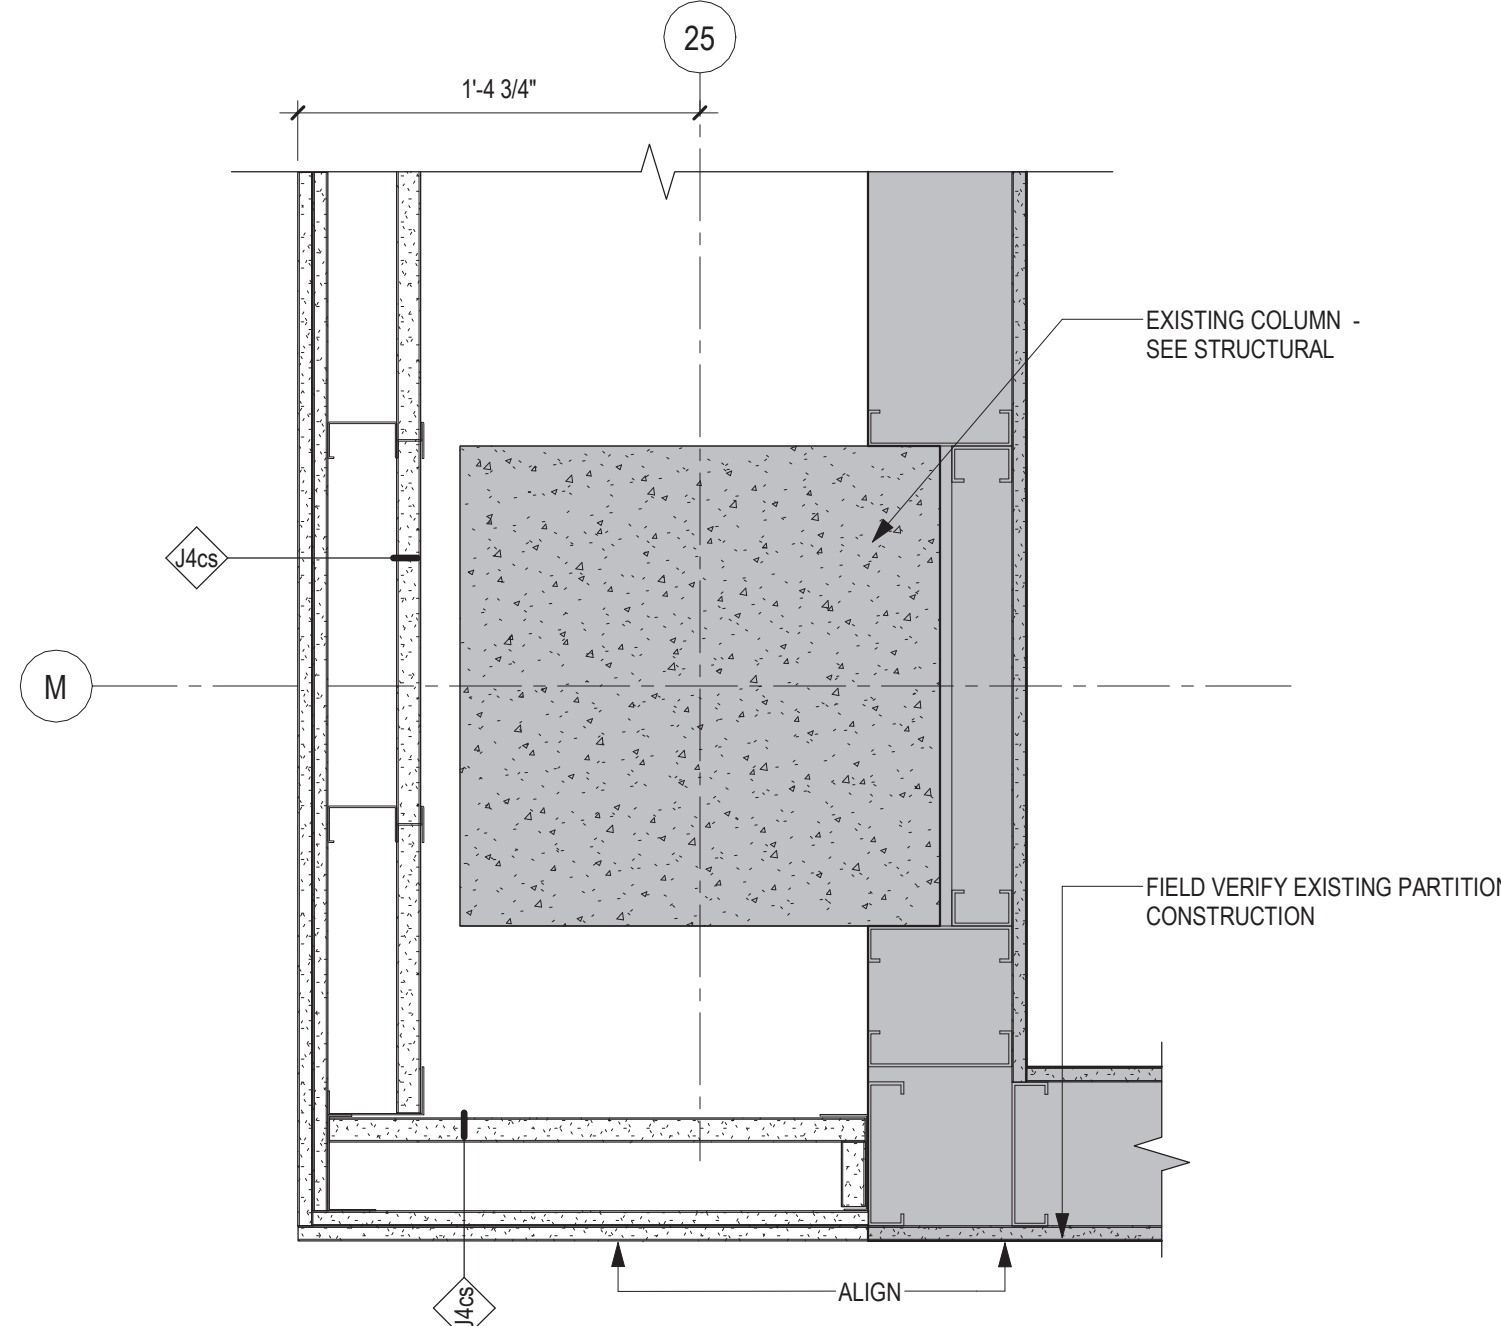


3 PLAN DETAIL - PARTITION @ COLUMN M-25
1 1/2" = 1'-0"

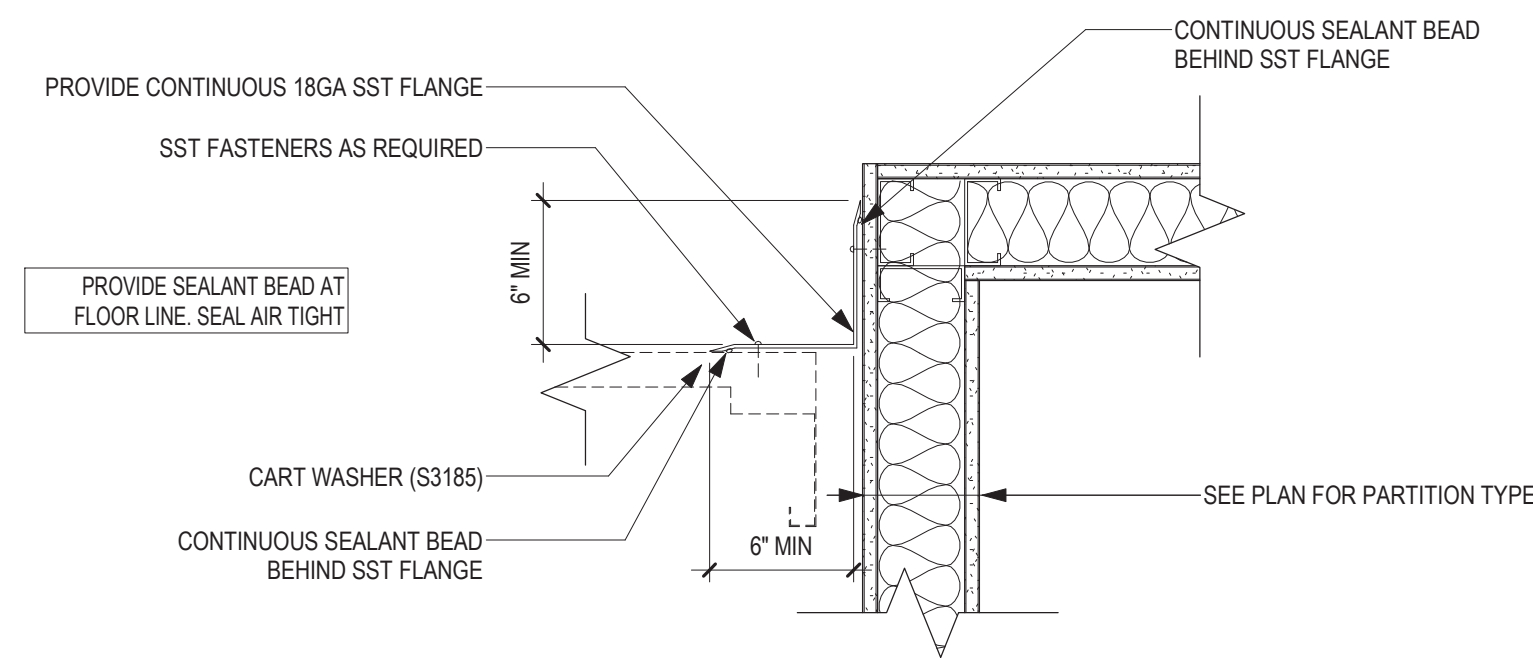


2 PLAN DETAIL - SST BARRIER FLANGE @ CART WASH
1 1/2" = 1'-0"

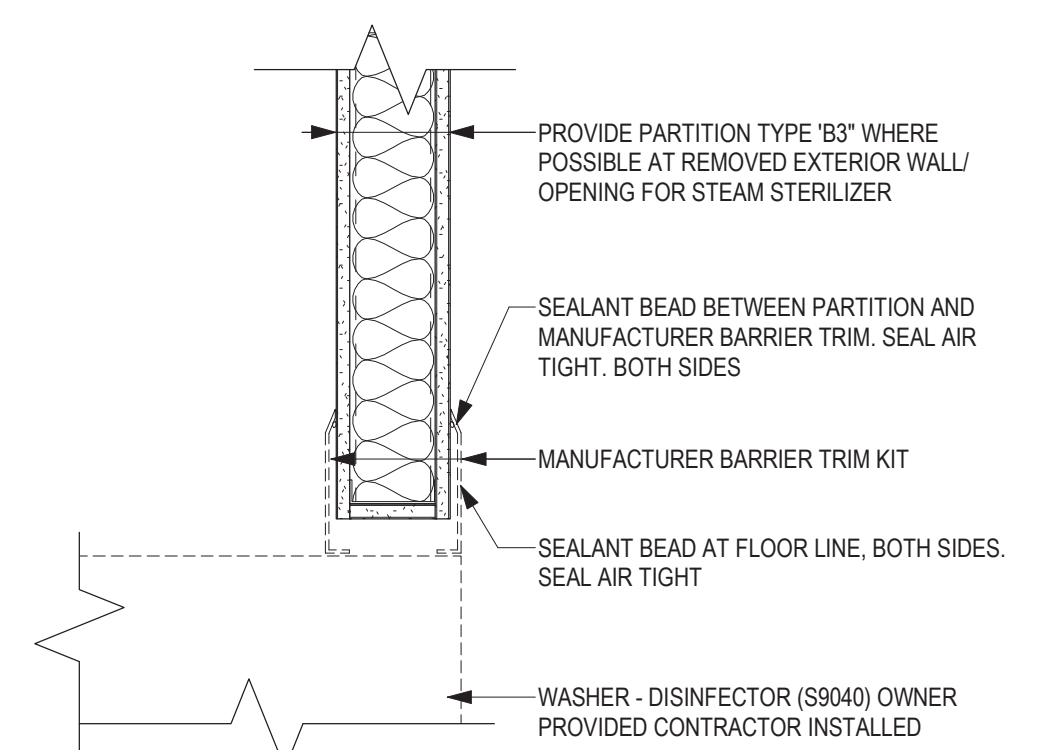


1 PLAN DETAIL - SST BARRIER FLANGE @ WASHER - DISINFECTOR
1 1/2" = 1'-0"

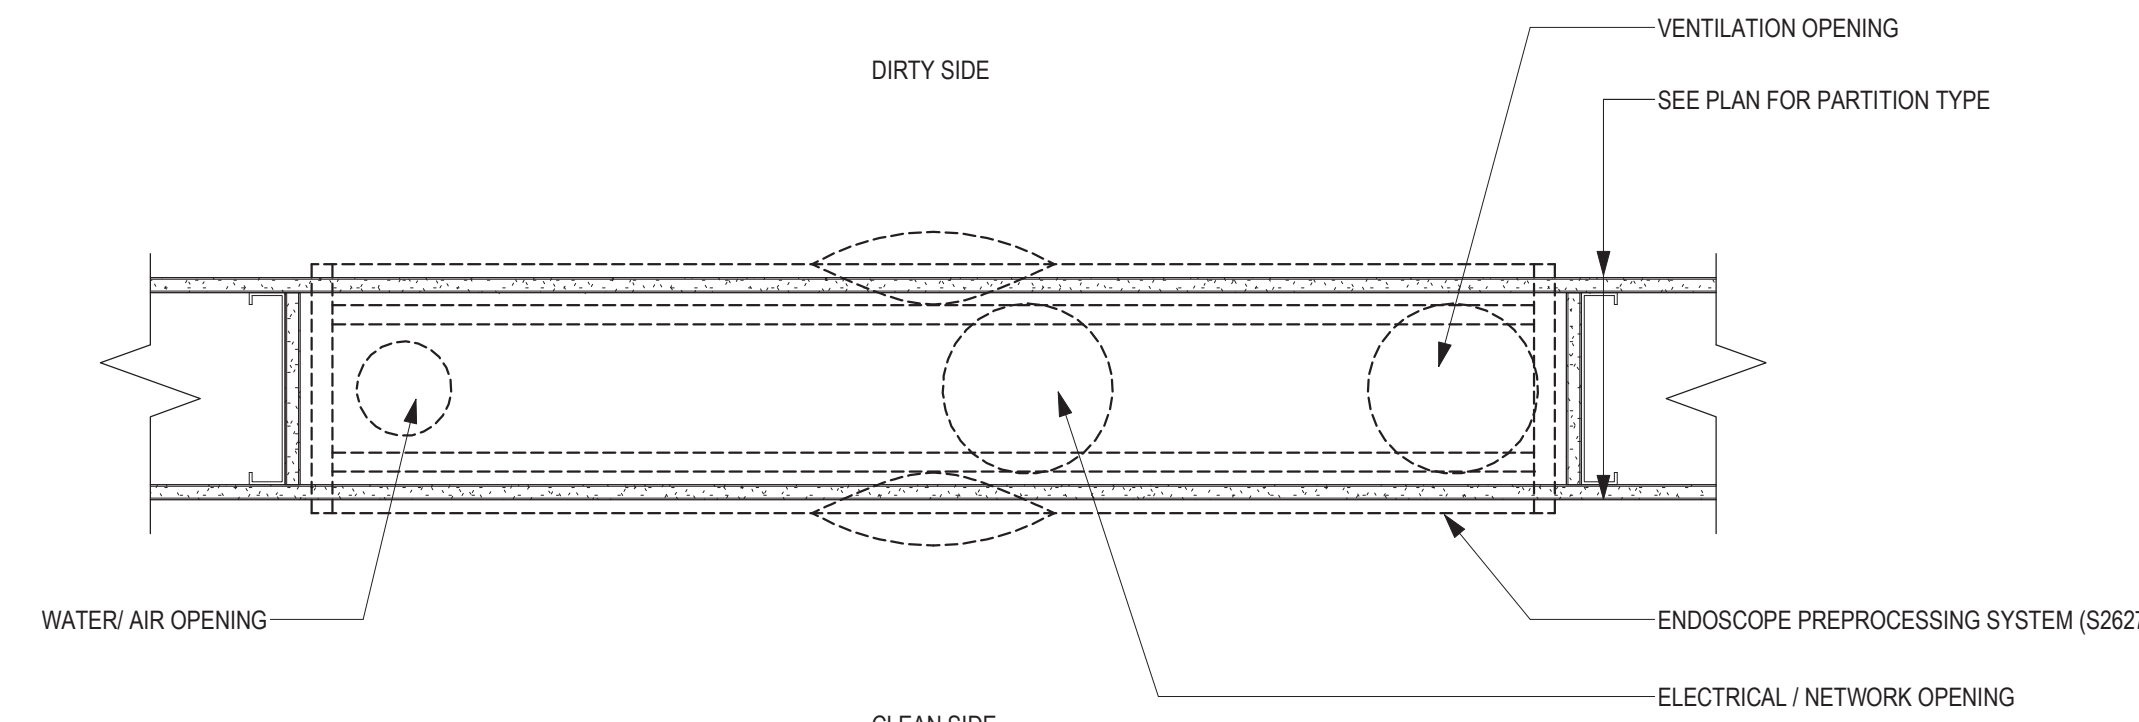


7 PLAN DETAIL - UNDERSIDE OF OPENING AT PREPROCESSOR FOR UTILITIES
1 1/2" = 1'-0"

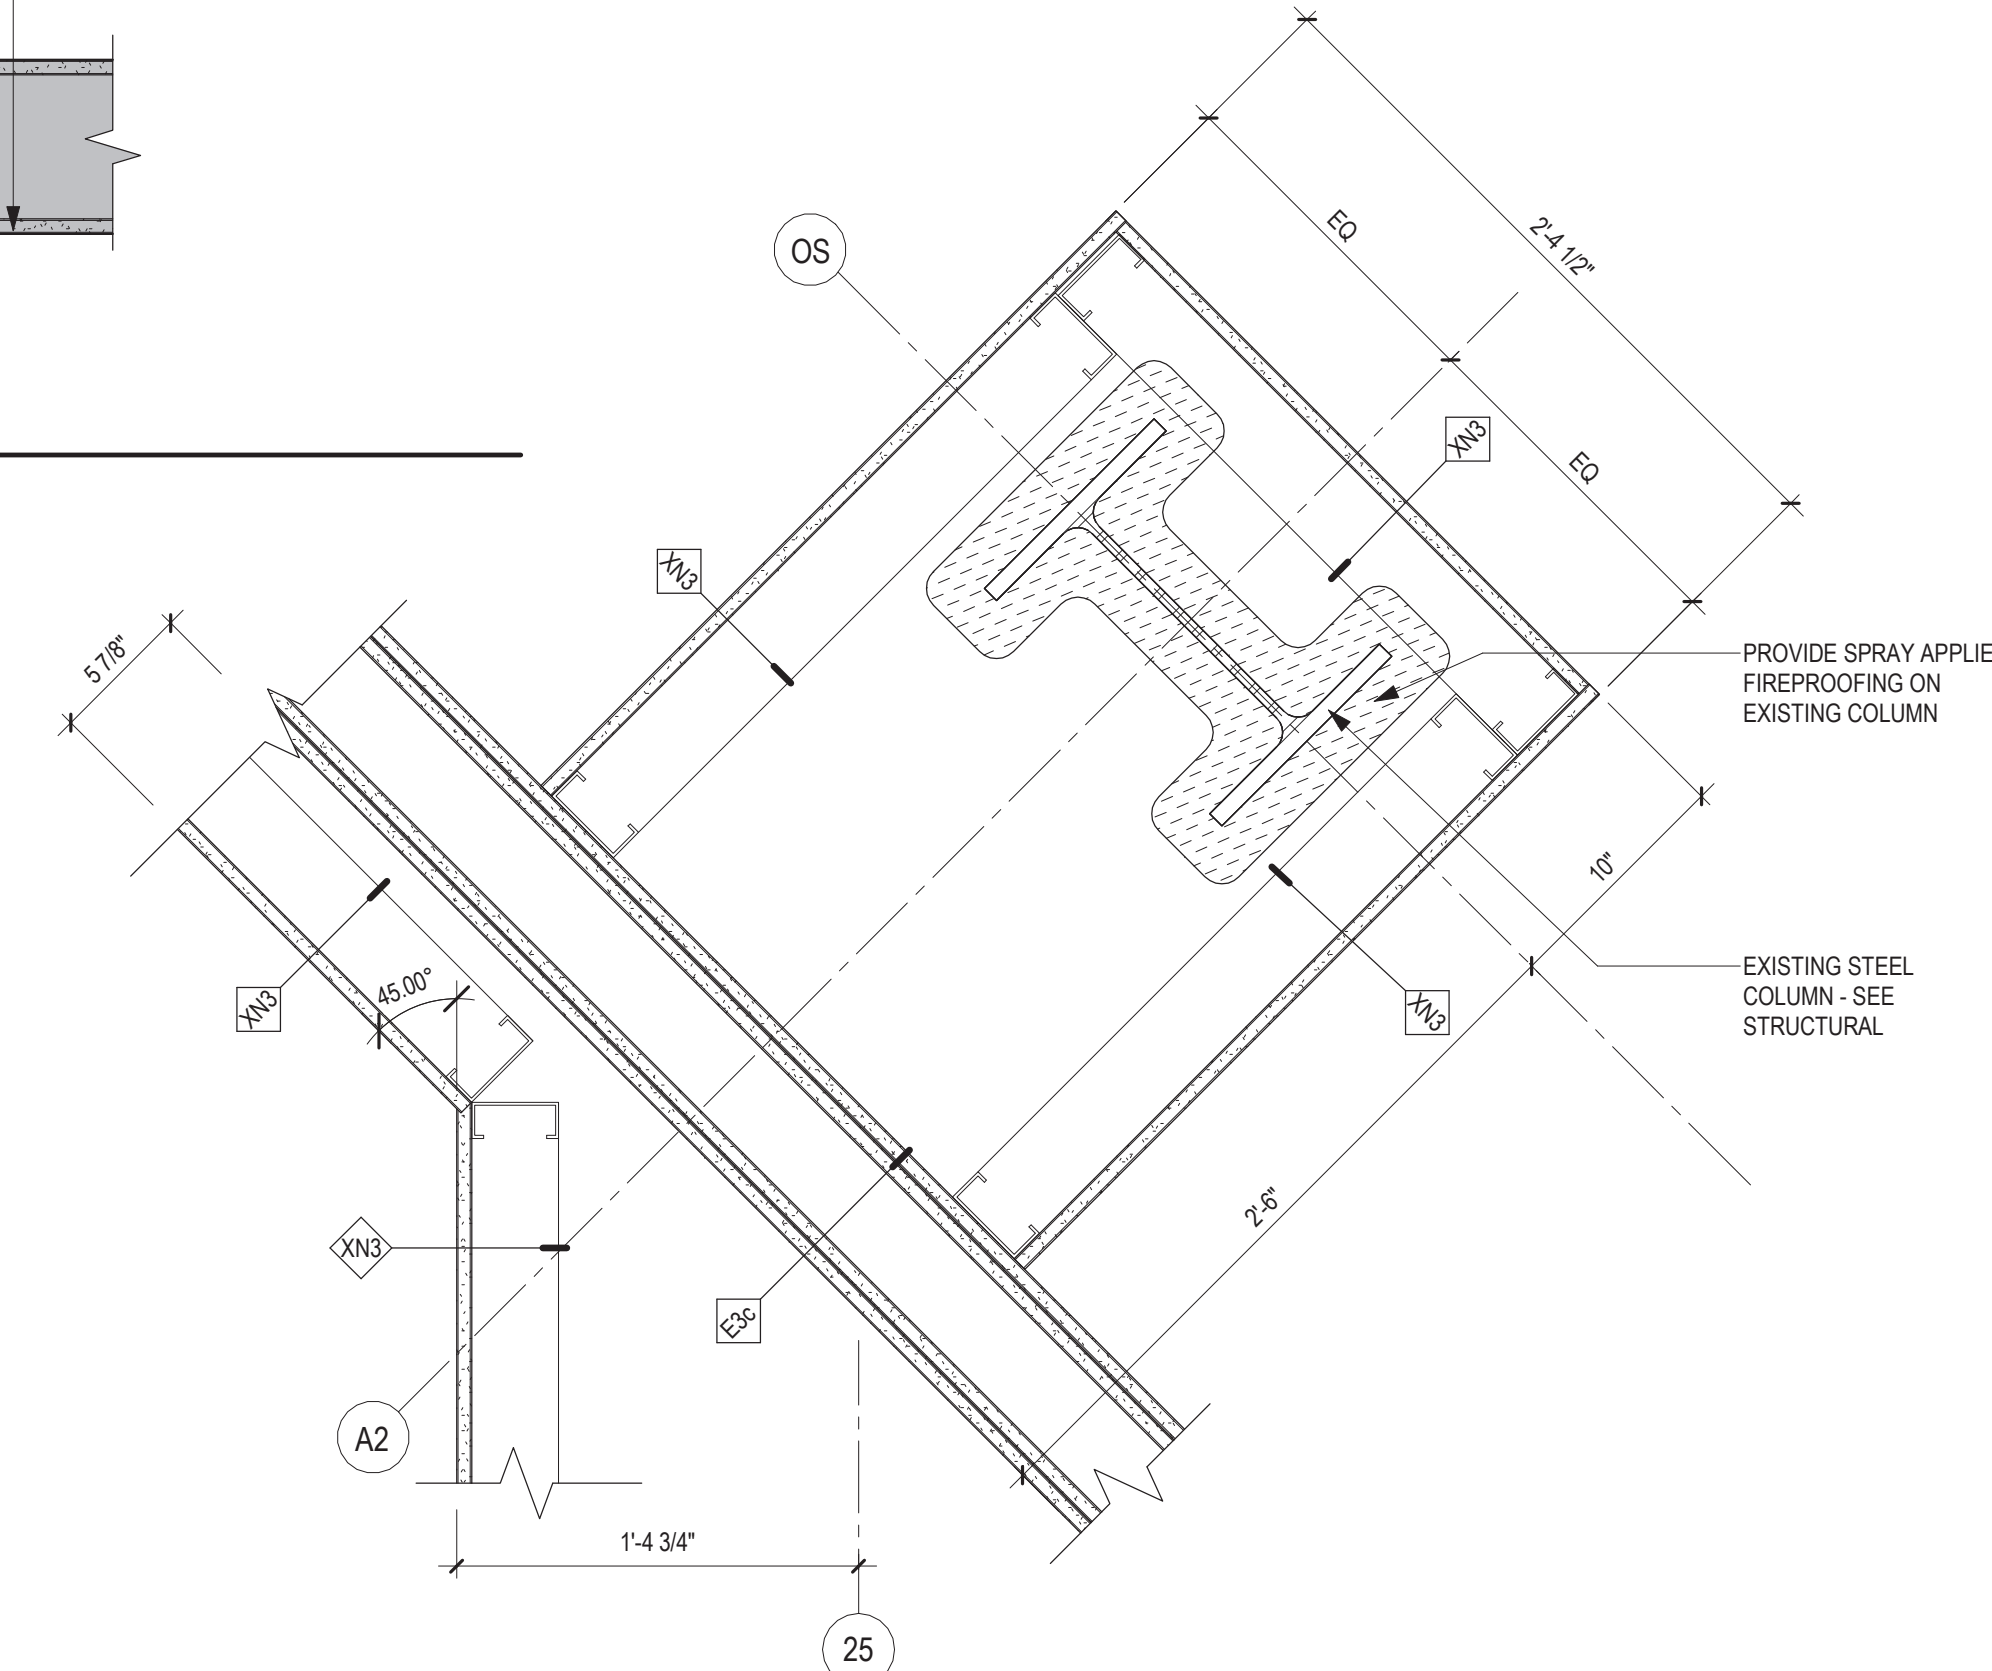


6 PLAN DETAIL - PARTITION @ COLUMN A2 - OS
1 1/2" = 1'-0"

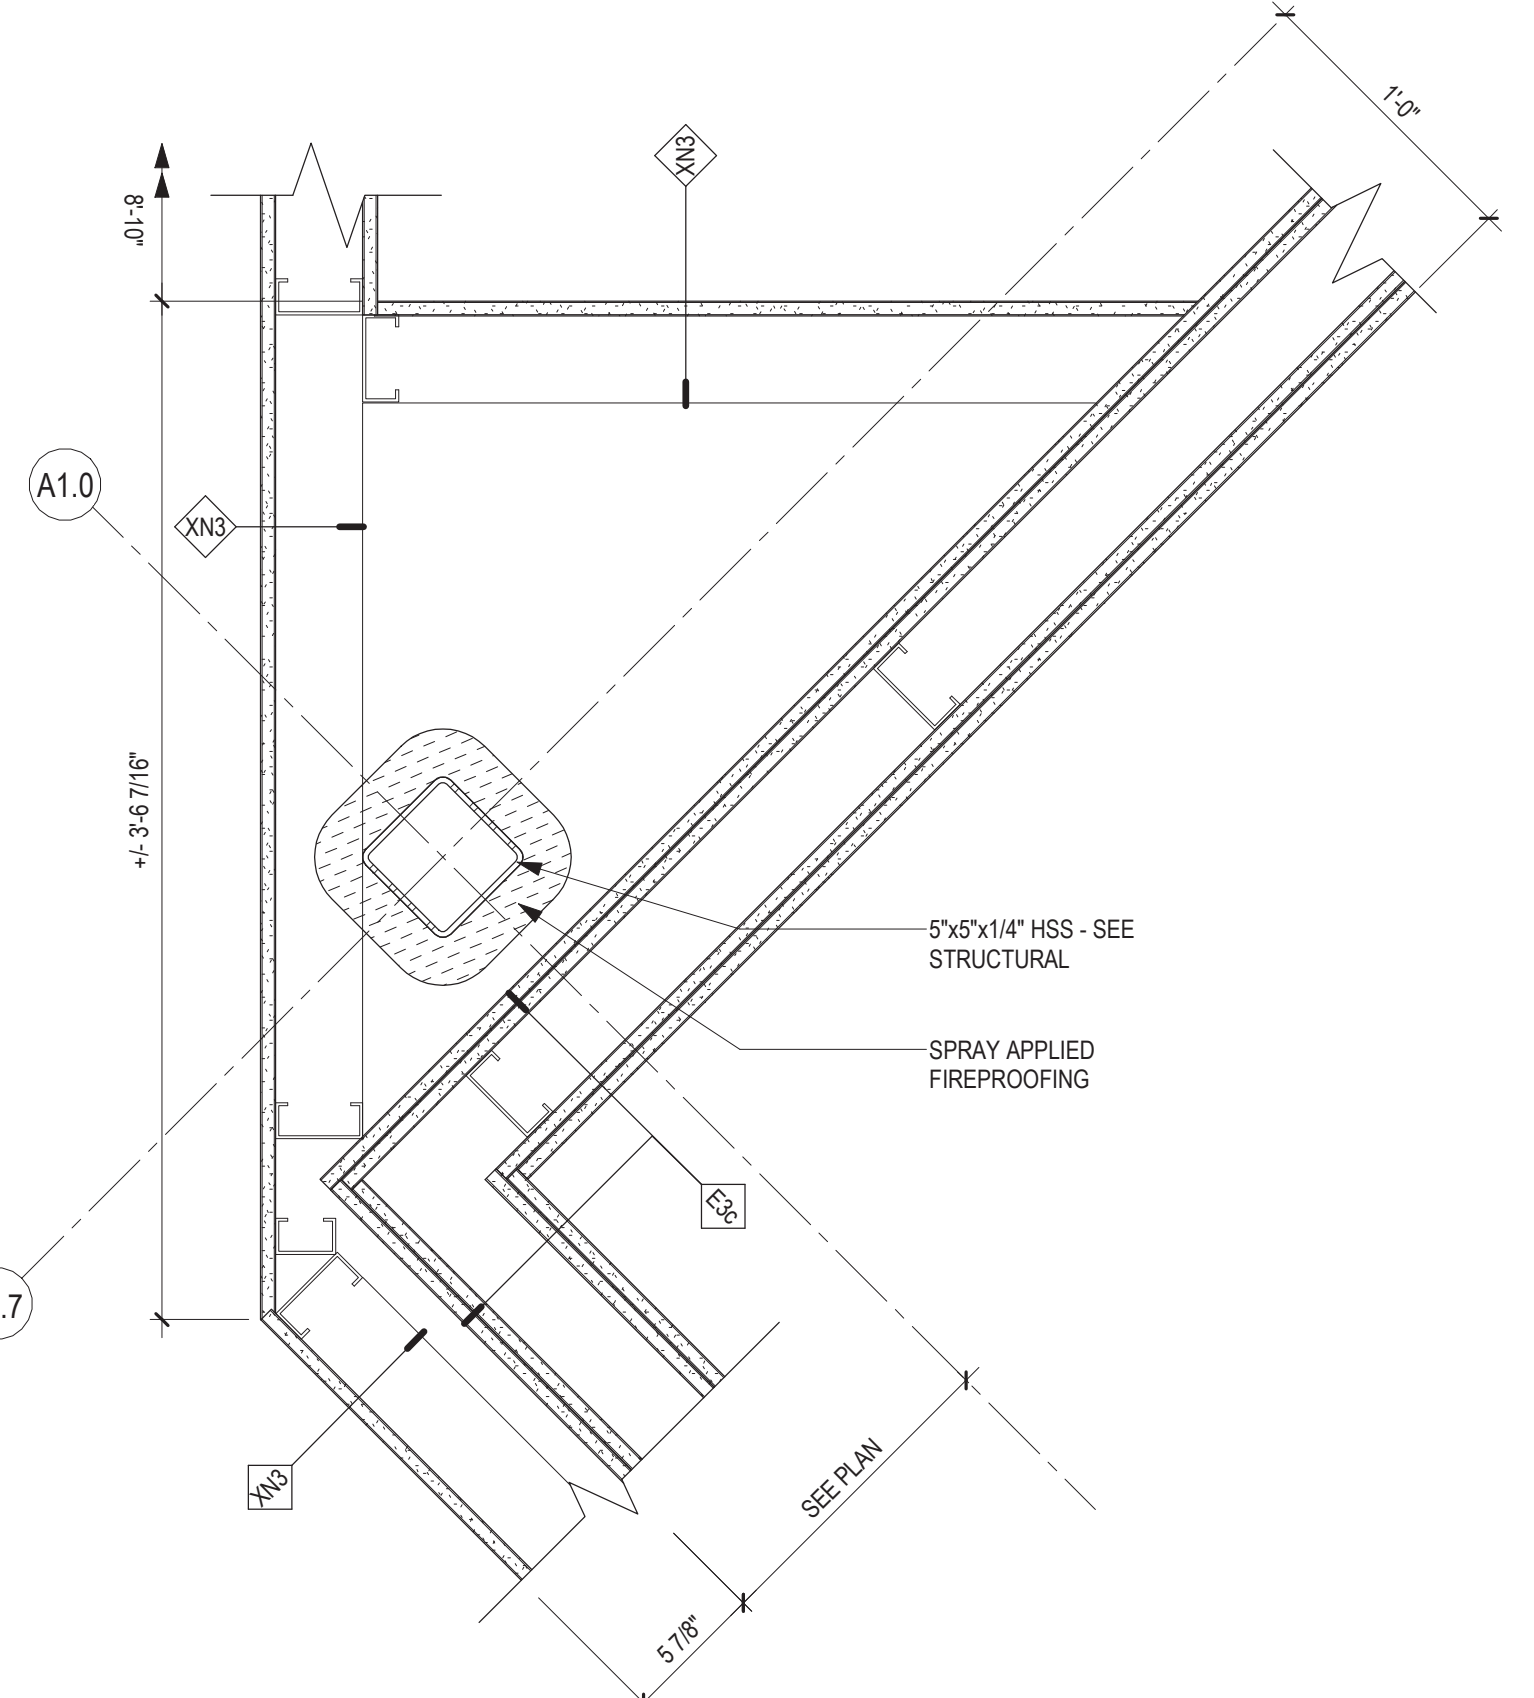



5 PLAN DETAIL - PARTITION @ COLUMN A1.7 - A1.0
1 1/2" = 1'-0"

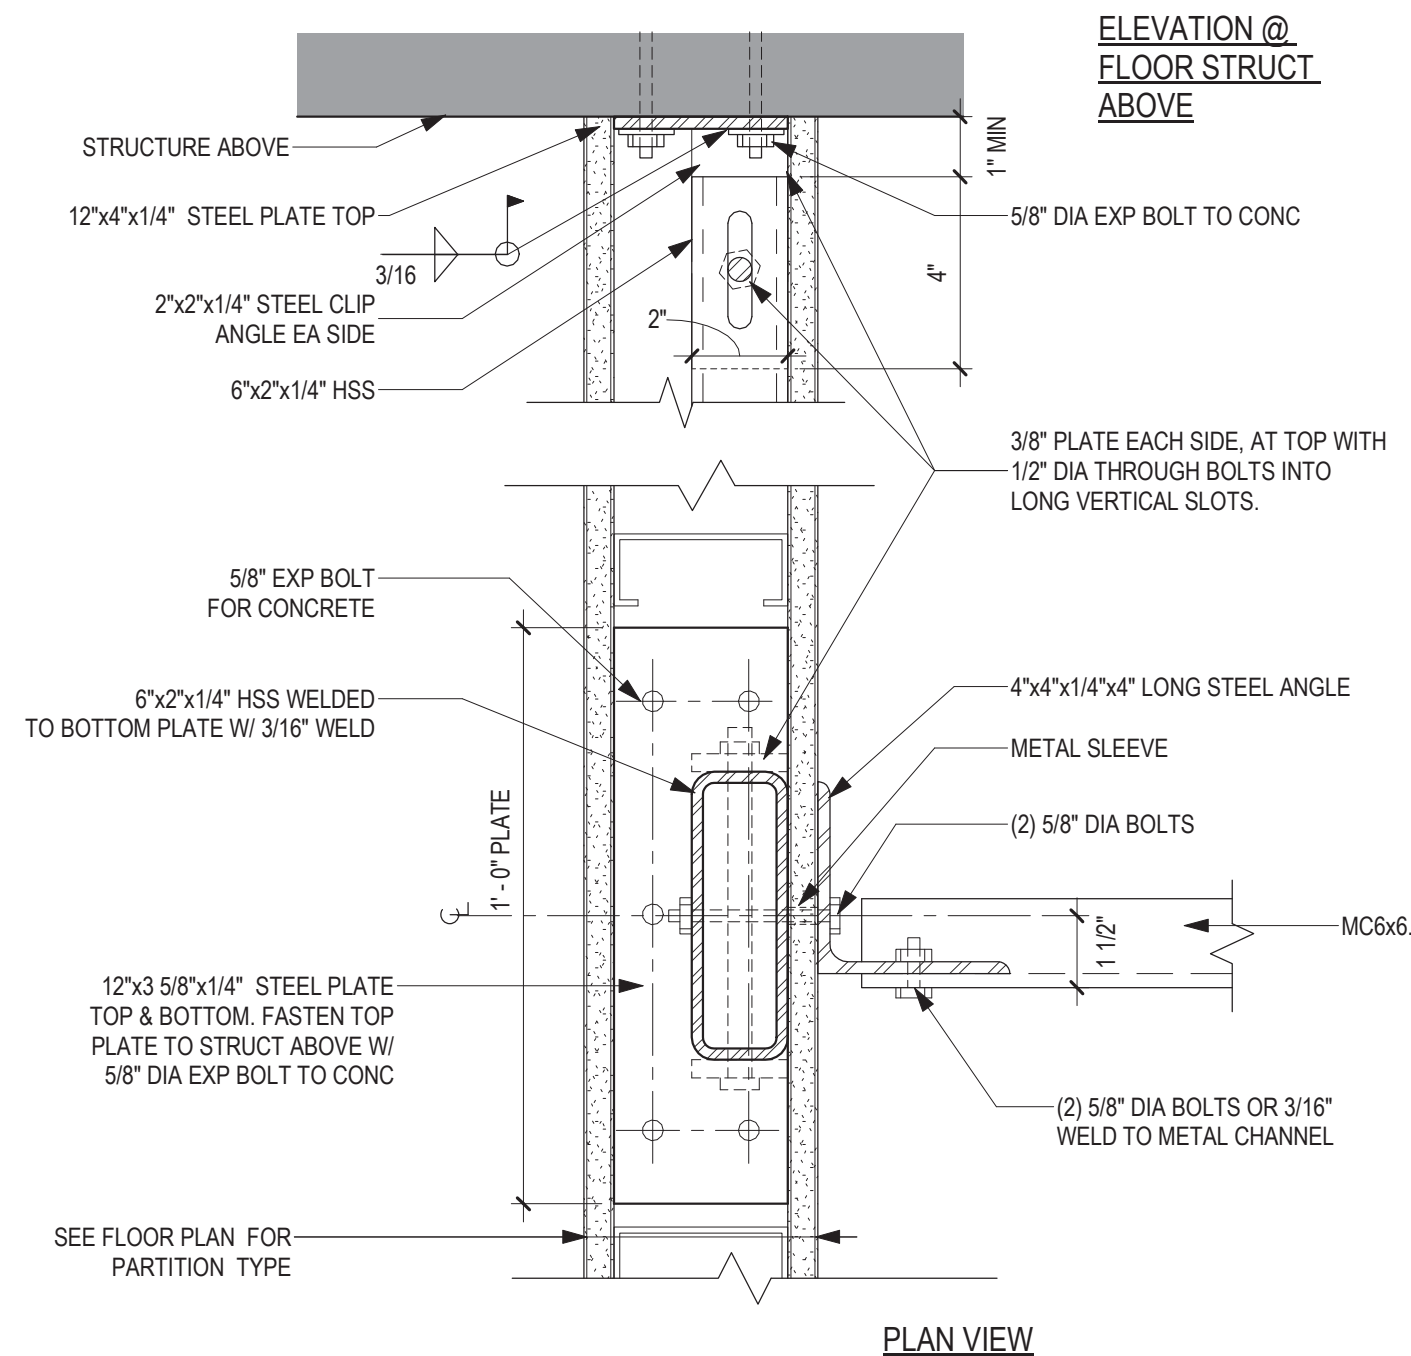

10 PLAN DETAIL - TOILET PARTITION METAL CHANNEL SUPPORT
3' = 1'-0"

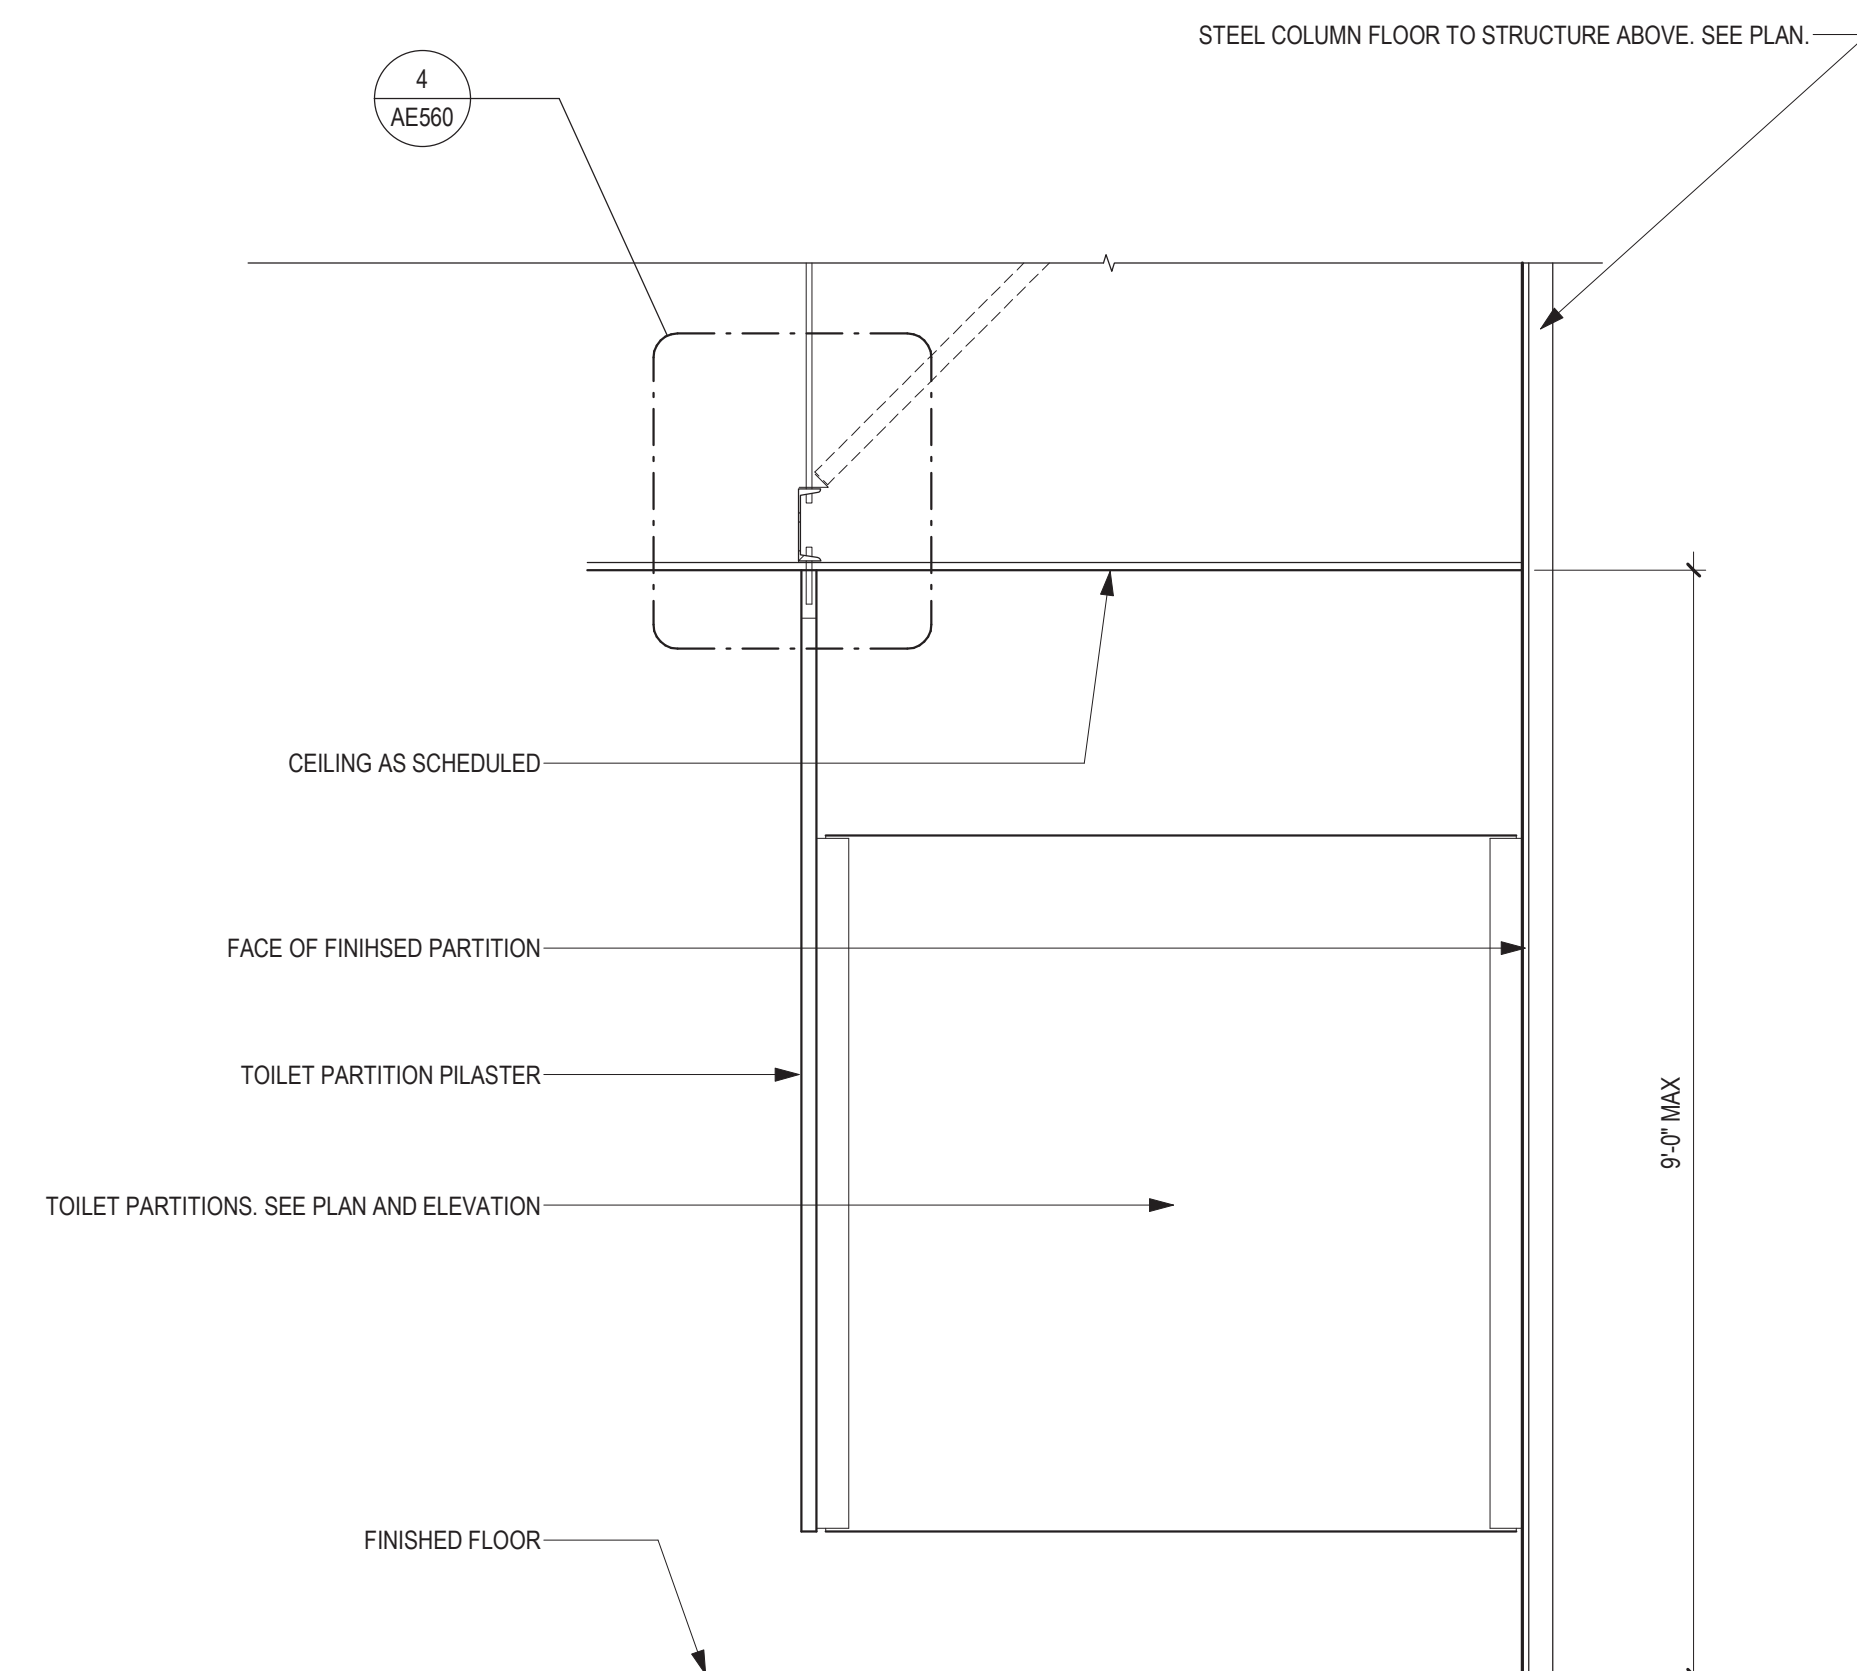

9 TOILET PARTITIONS REFERENCE DIAGRAM
3/4" = 1'-0"

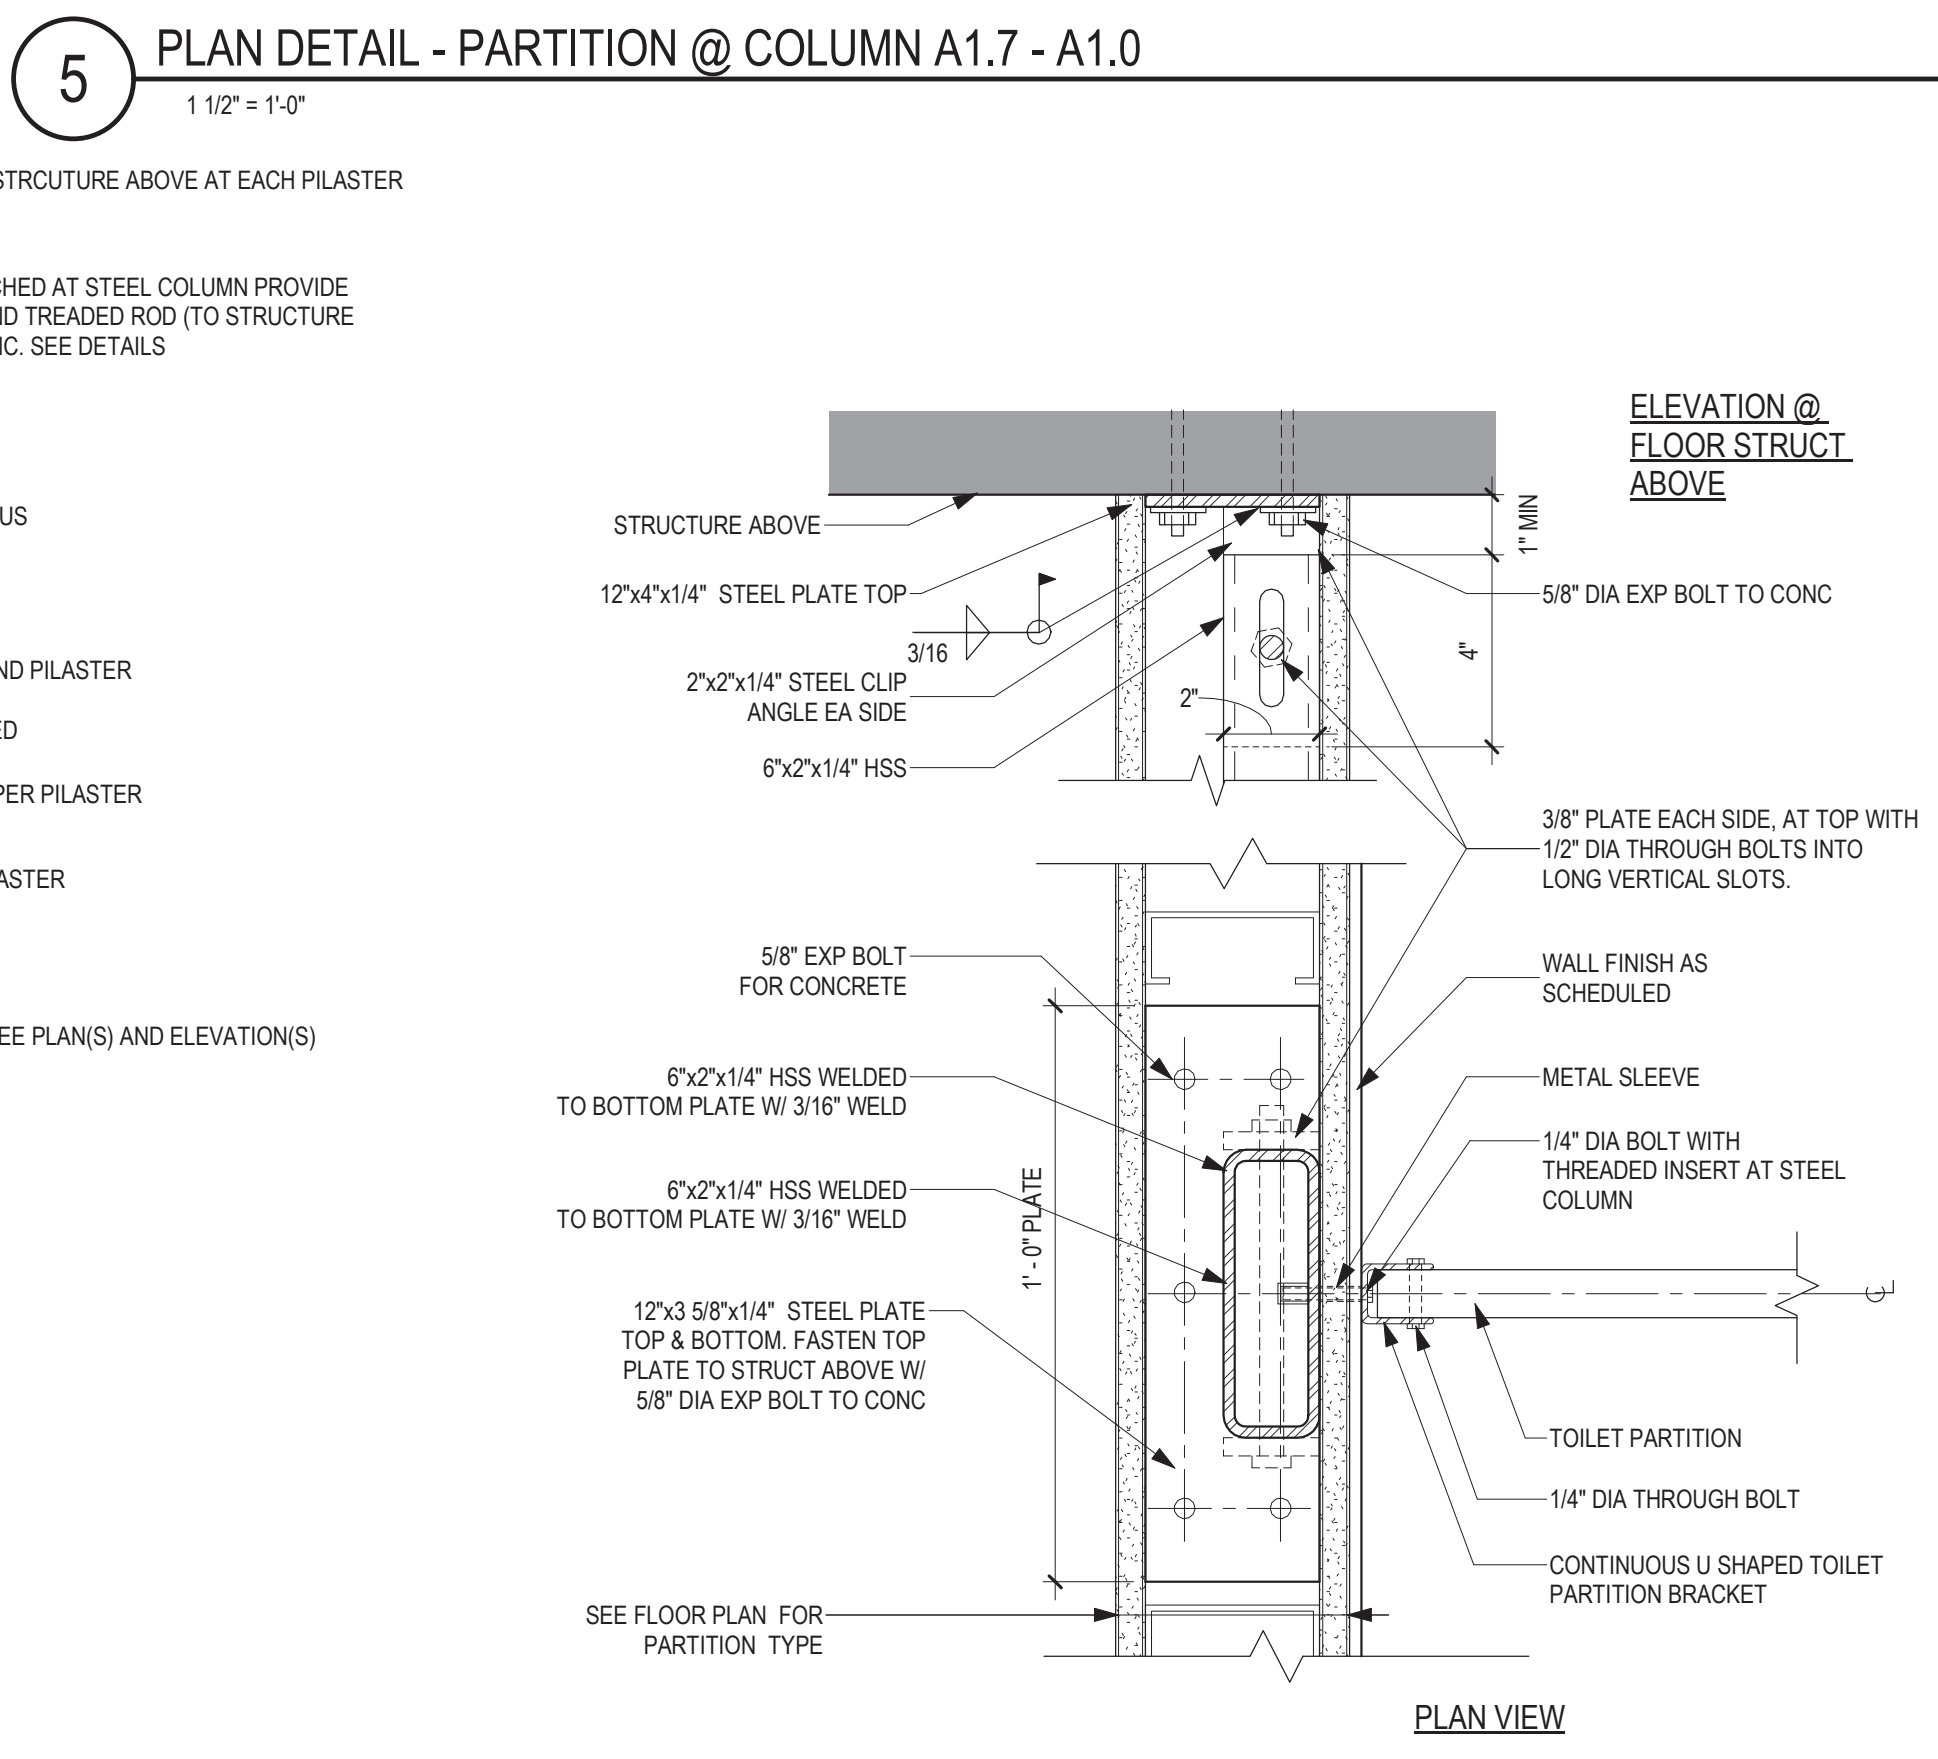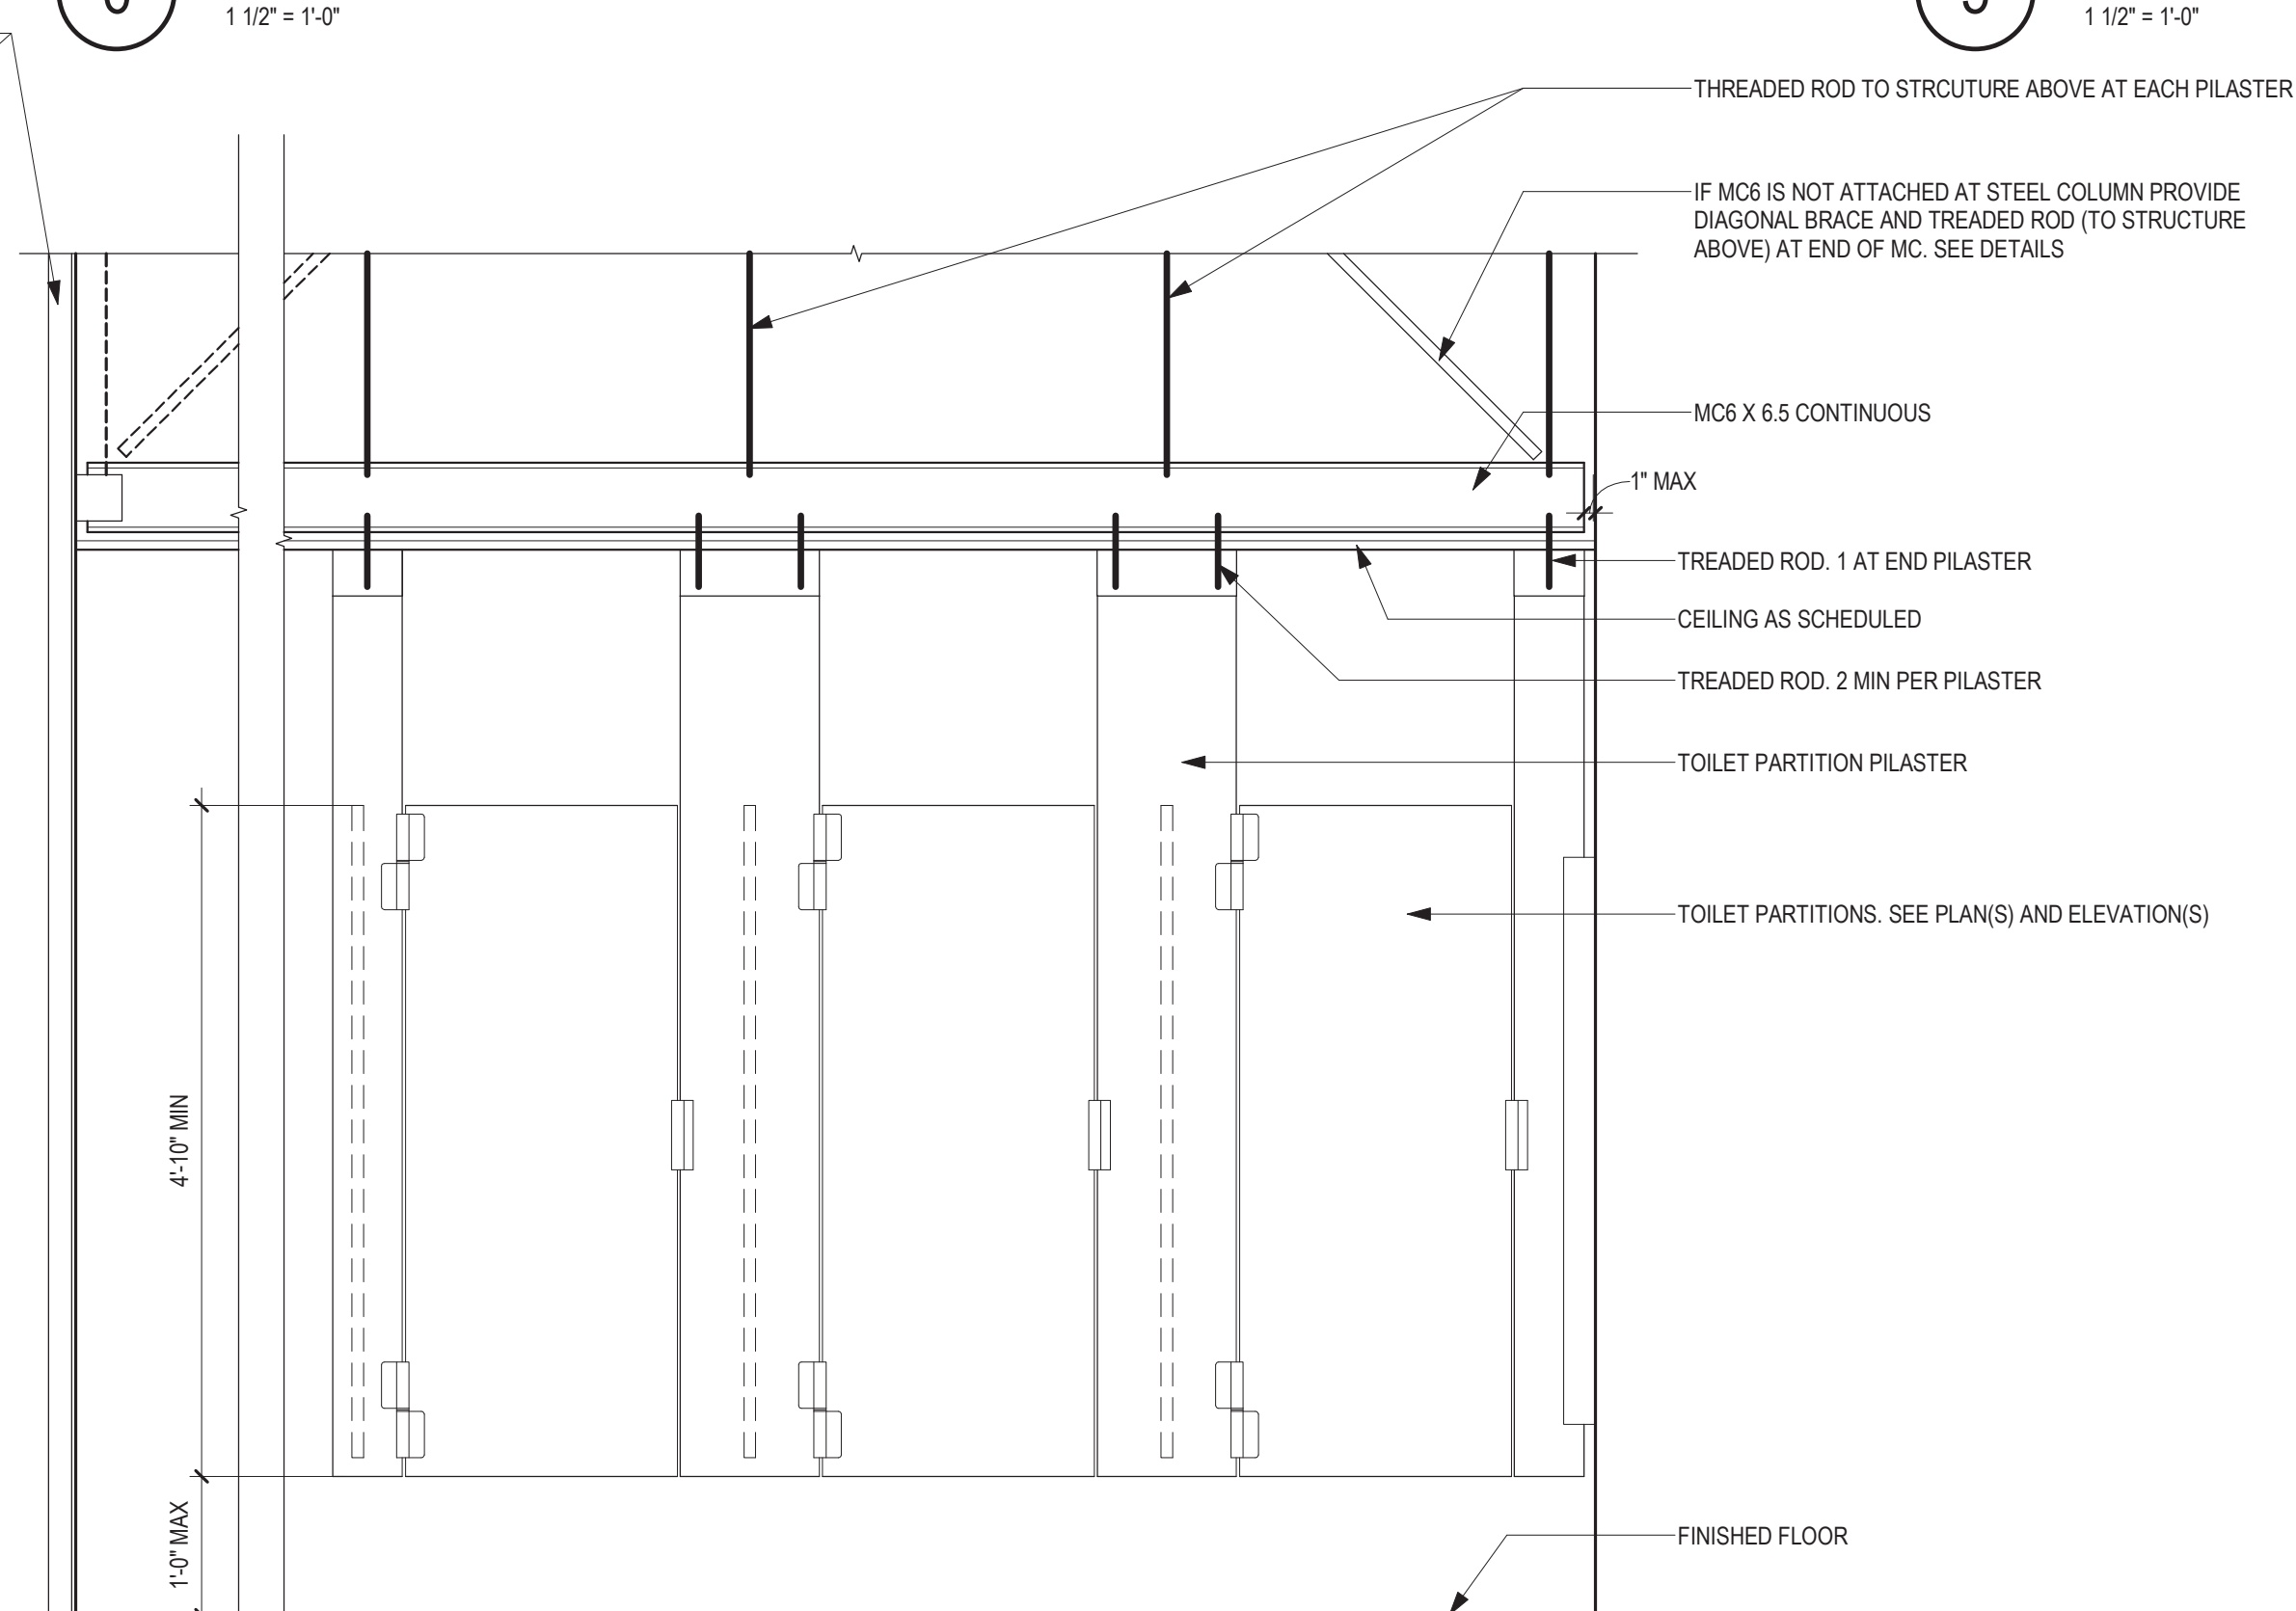

8 PLAN DETAIL - TOILET PARTITION SUPPORT
3' = 1'-0"

Revisions: Date:	CONSULTANT IMEG	ARCHITECT/ENGINEER OF RECORD ANDERSON 13605 1st Ave. N. #100 Plymouth, MN 55441 P 763.412.4000 F 763.412.4090 ae-mn.com Anderson Engineering of Minnesota, LLC Proj # 16684	STAMP DATE: 08/04/2022 License # 9335	Office of Construction and Facilities Management U.S. Department of Veterans Affairs	Drawing Title INTERIOR PLAN DETAILS Approved:	Phase BID DOCUMENTS FULLY SPRINKLERED	Project Title CONSTRUCT NEW SPS Location Sioux Falls, SD. Issue Date 08/04/2022 Checked Checker Drawn Author Project Number 438-460 Building Number 5 Drawing Number AE543
--	---------------------------------------	--	--	--	--	--	--

C:\Users\Public\Documents\Revit Projects\16684-R21_gbarani@ae-mn.com.rvt
7/7/2023 1:28:25 PM
VA FORM 08 - 6231

A

B

C


D

E


F

7/7/2023 1:28:27 PM


C:\Users\Public\Documents\Revit Projects\16584-R21_gbarani@ae-mn.com.rvt

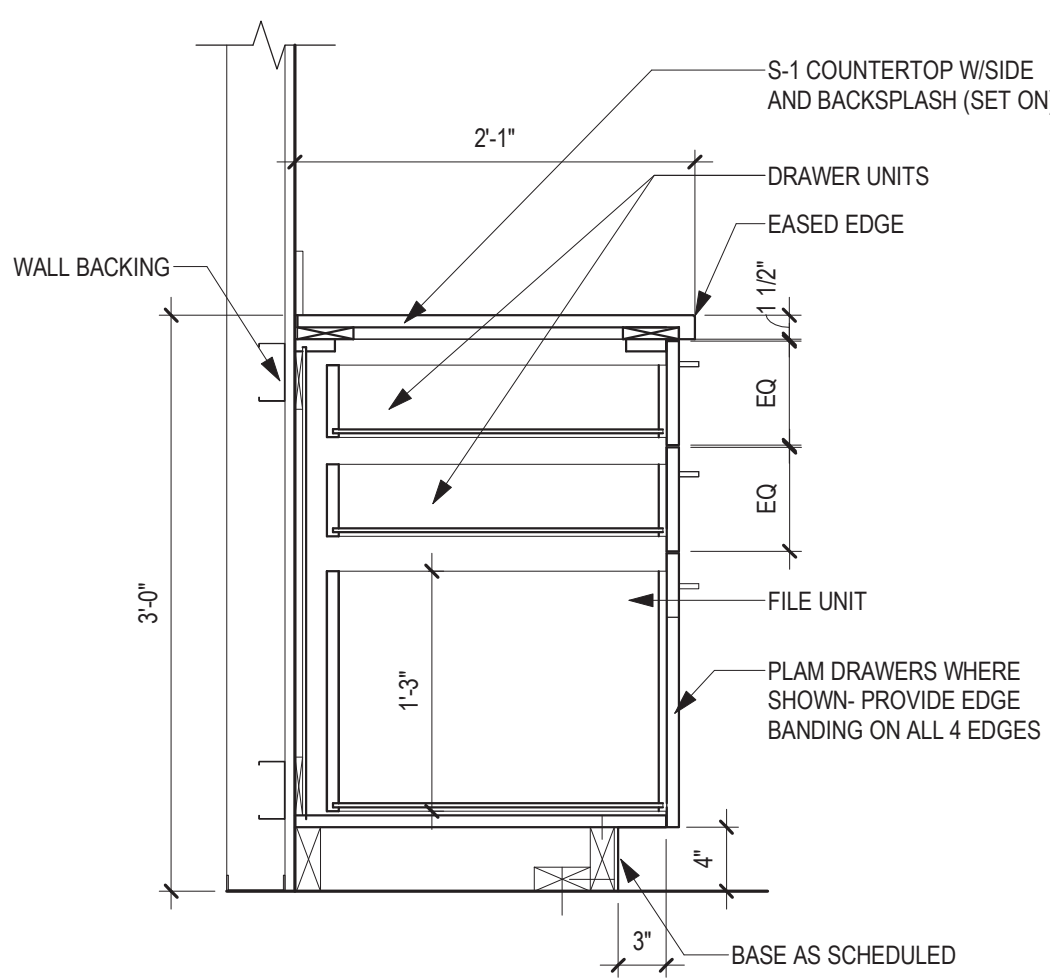


5 SECTION - BASE CABINET 3 DRAWER W/ 2 EQ
1" = 1'-0"

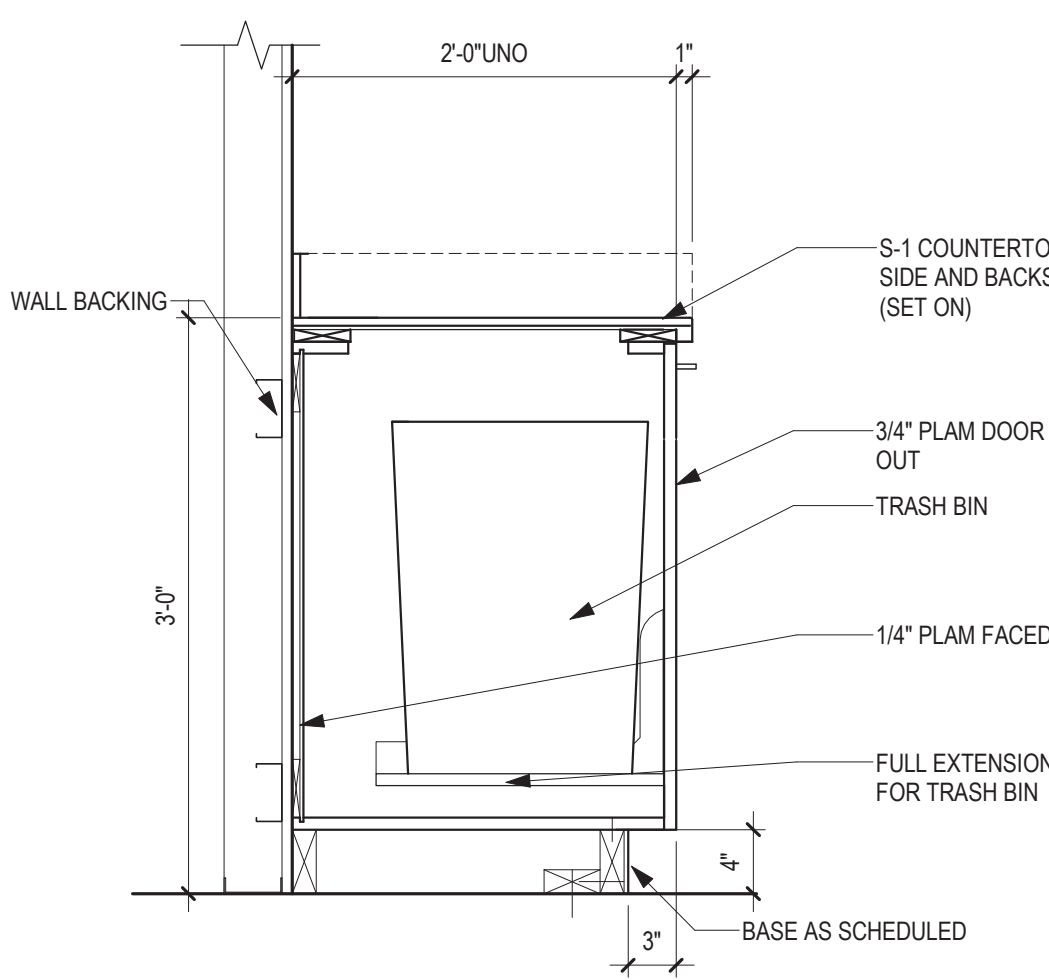


4 SECTION - BASE CABINET TRASH
1" = 1'-0"

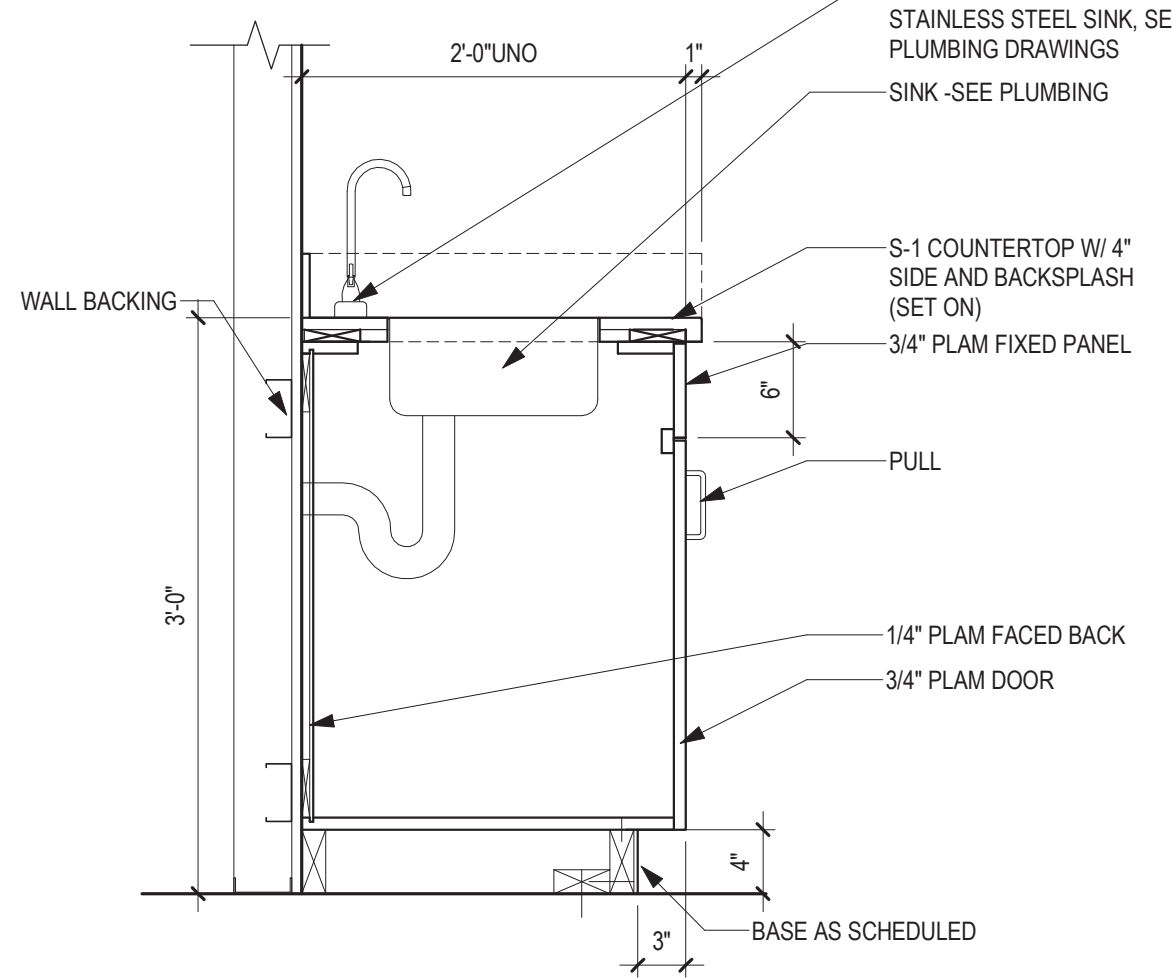


3 SECTION - BASE CABINET WITH SINK
1" = 1'-0"

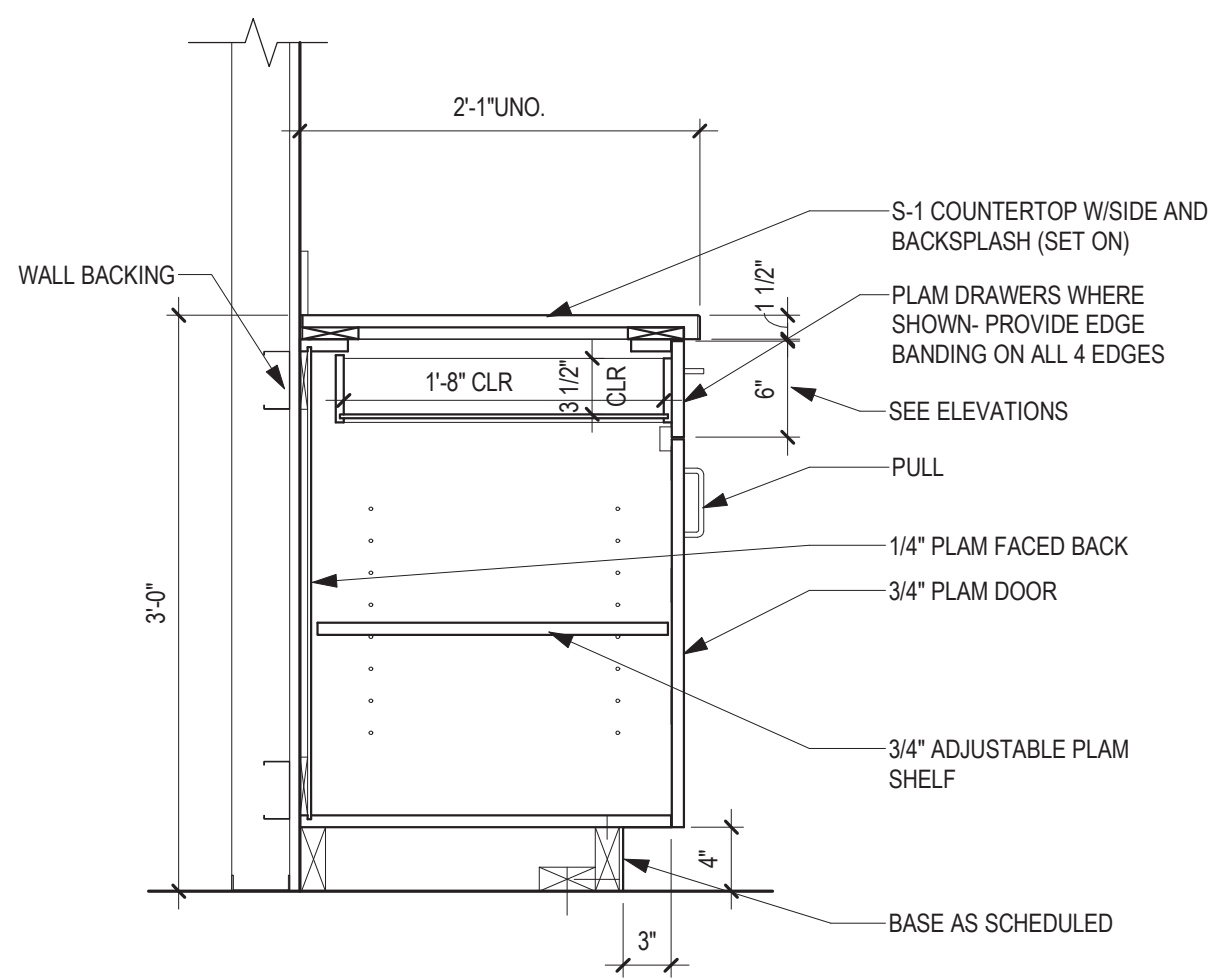



2 SECTION - BASE CABINET DRAWER & DOOR
1" = 1'-0"

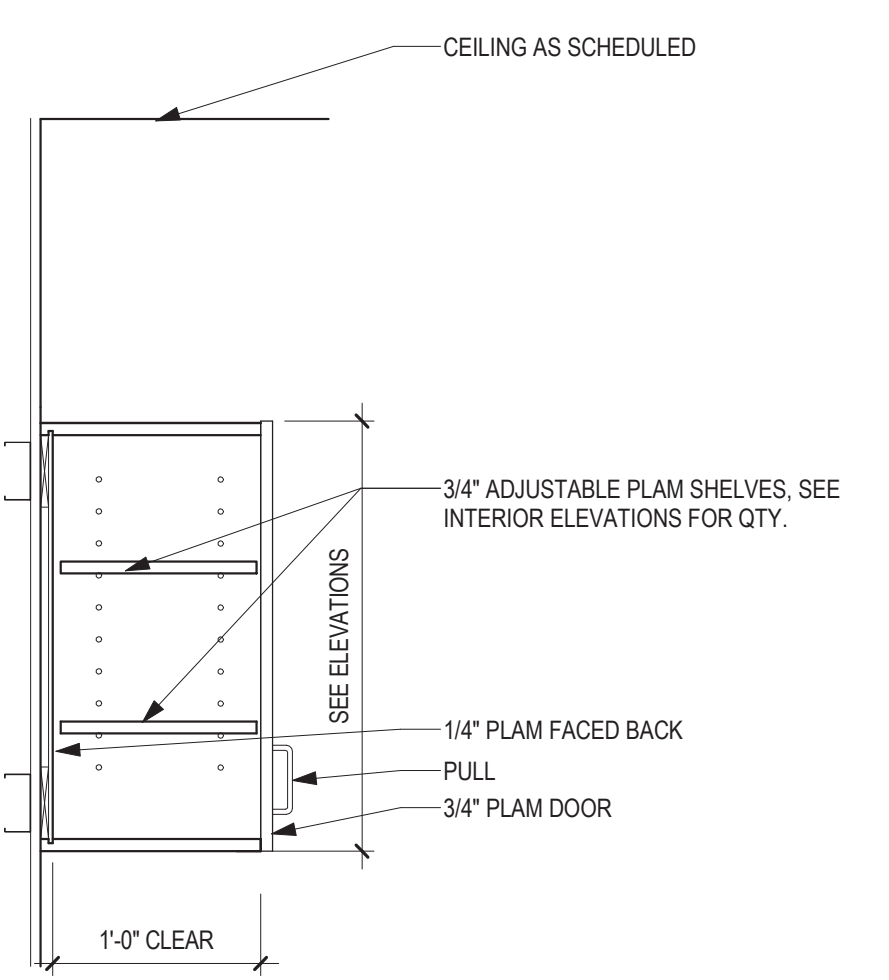


1 SECTION - WALL CABINET WITH DOOR
1" = 1'-0"

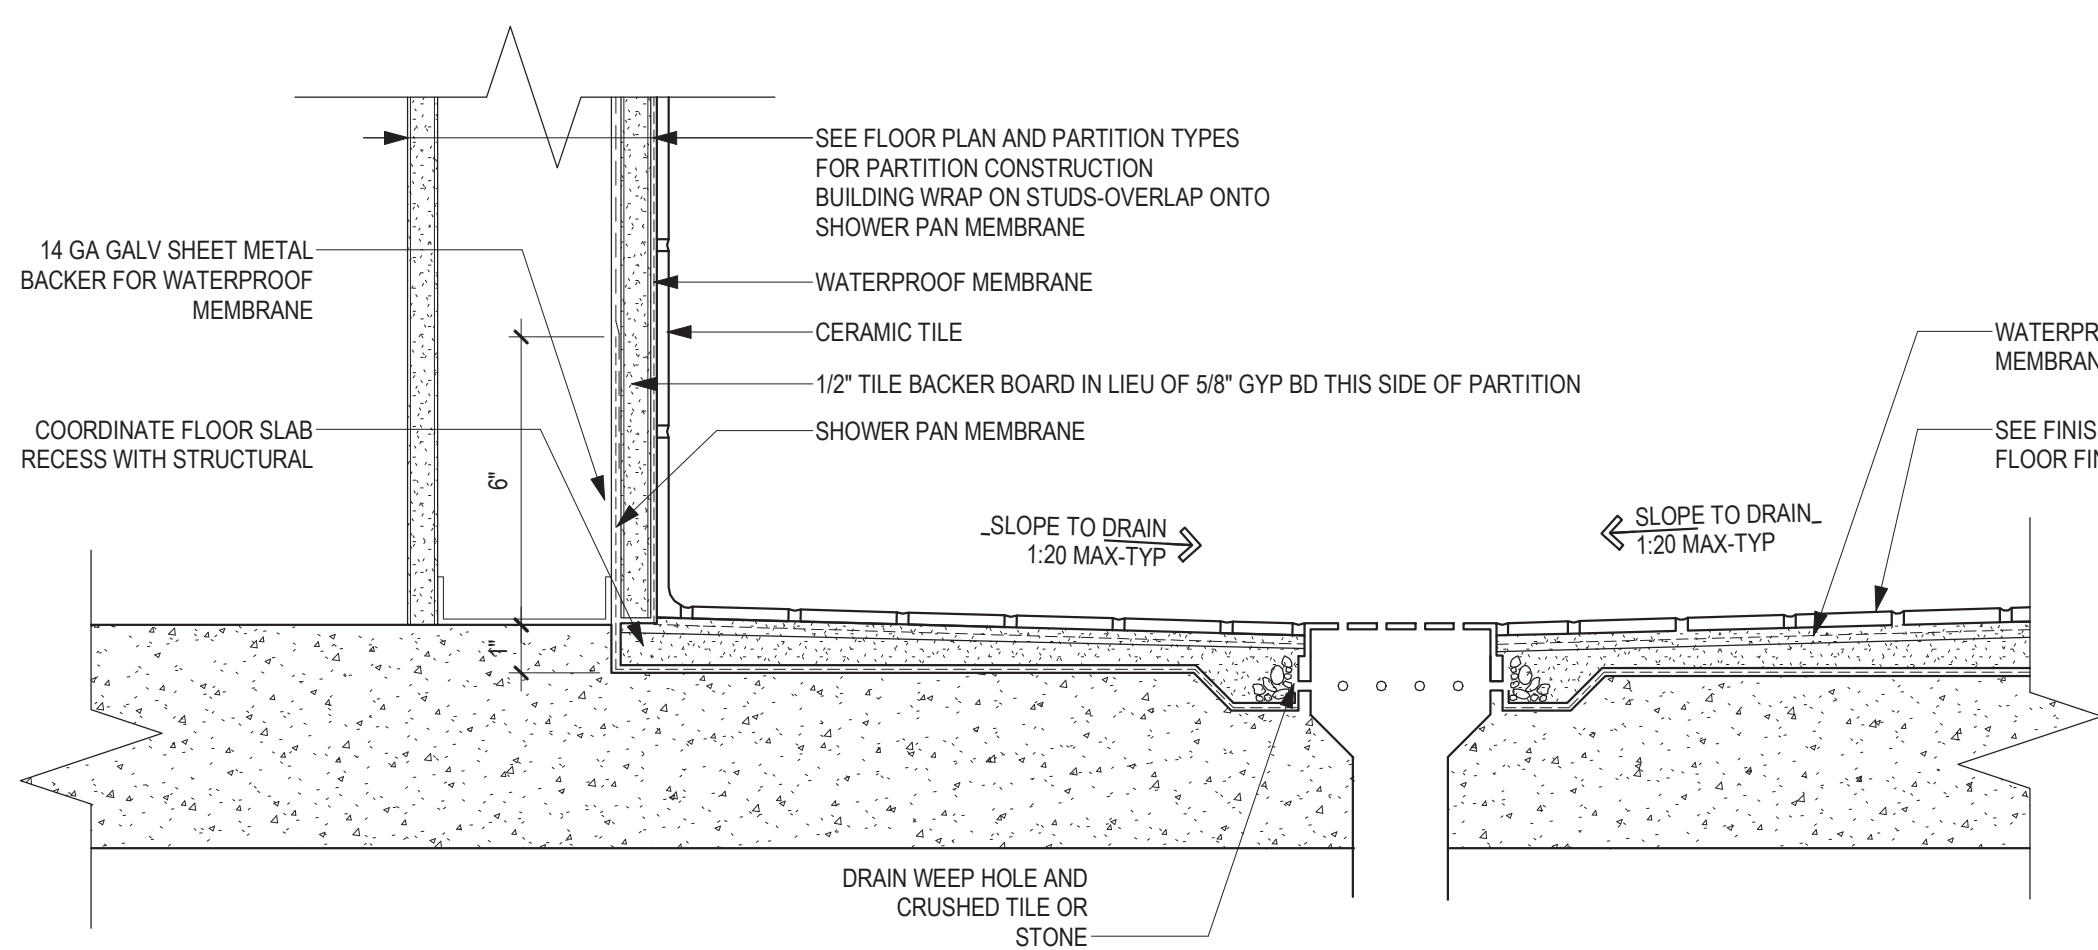


10 SECTION DETAIL INTERIOR - WATERPROOFING AT TOILET ROOM FLOOR
3" = 1'-0"

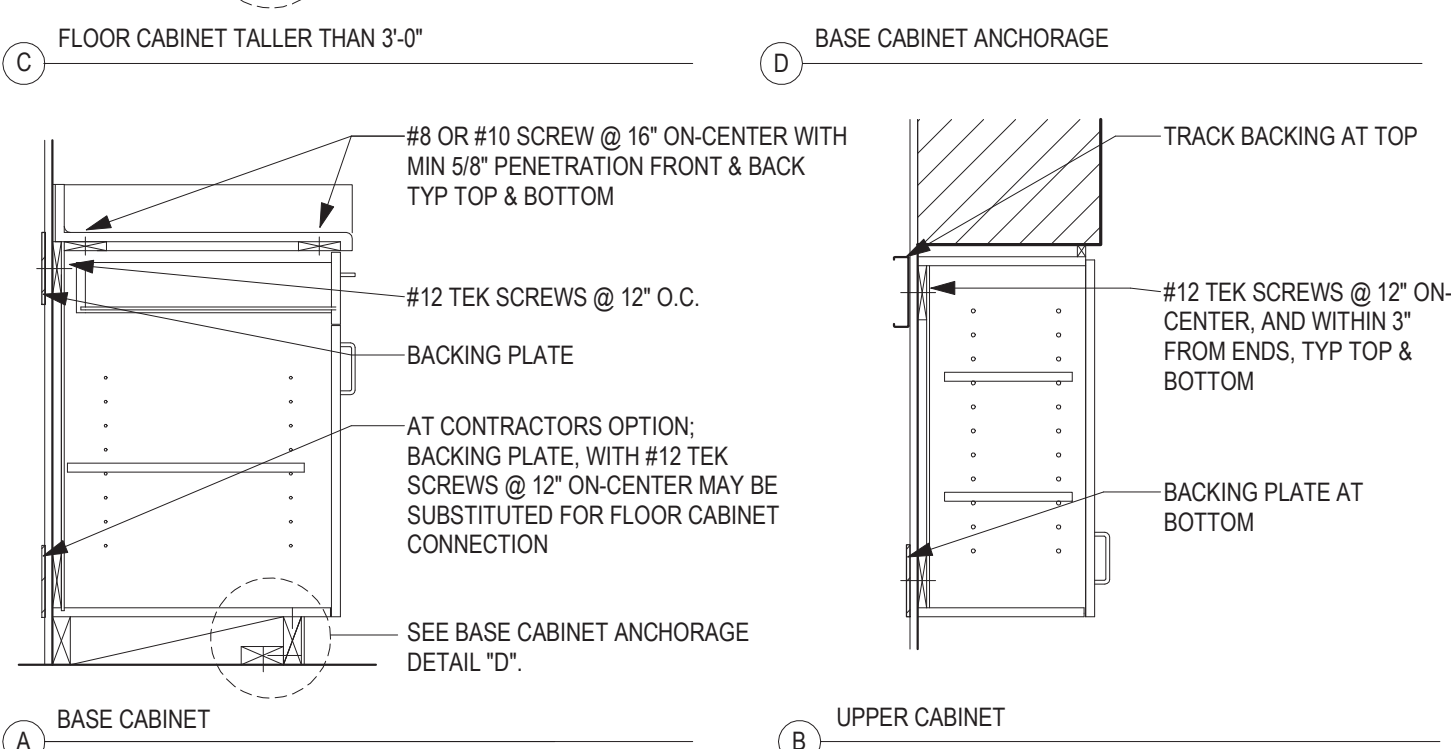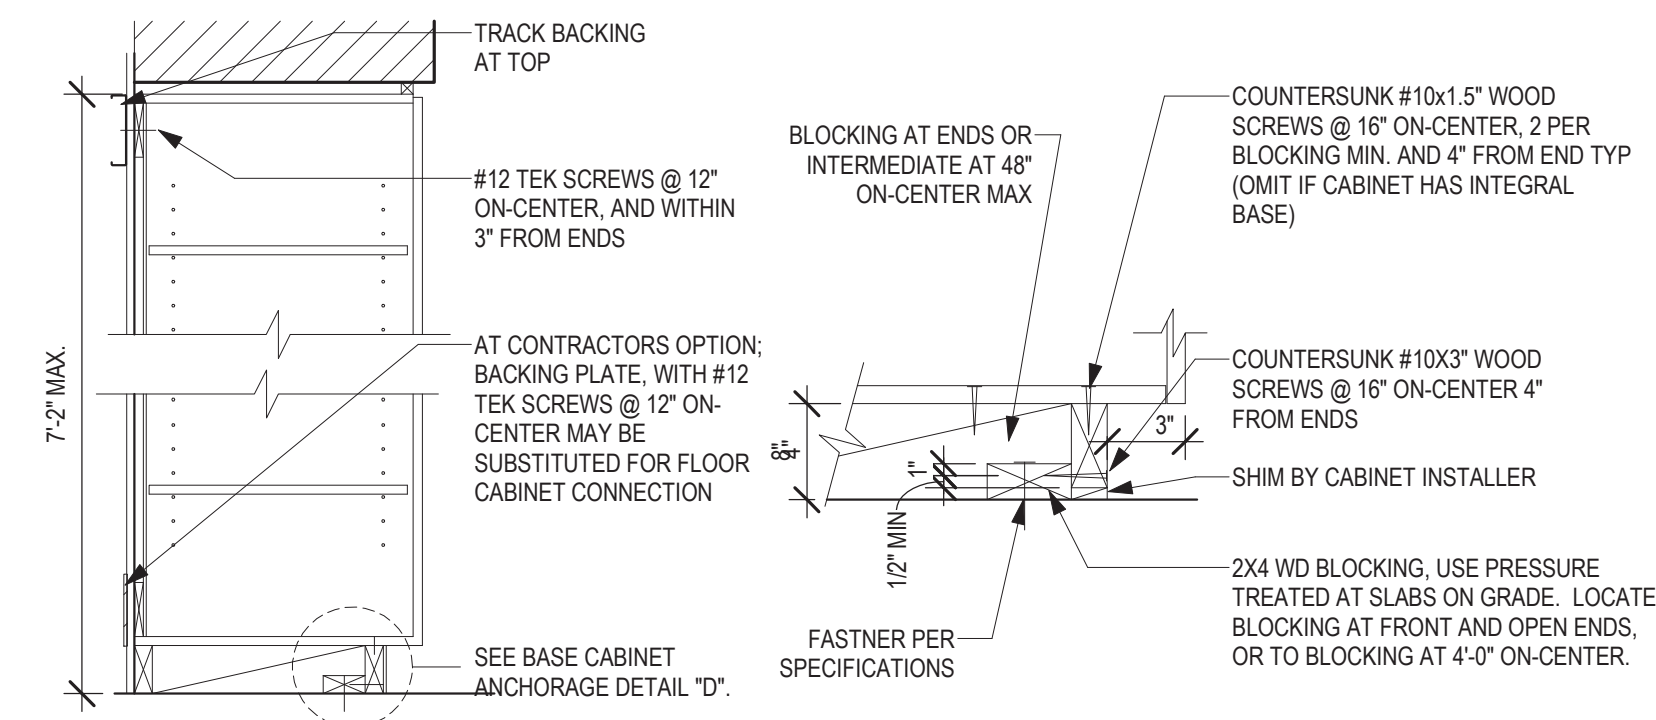


9 CASEWORK ANCHORAGE
3/4" = 1'-0"

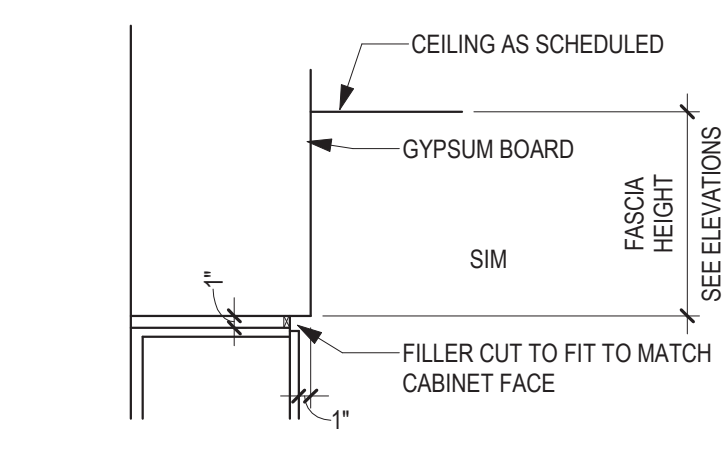


7 CASEWORK / LOCKERS AT GYP BD SOFFIT
3/4" = 1'-0"

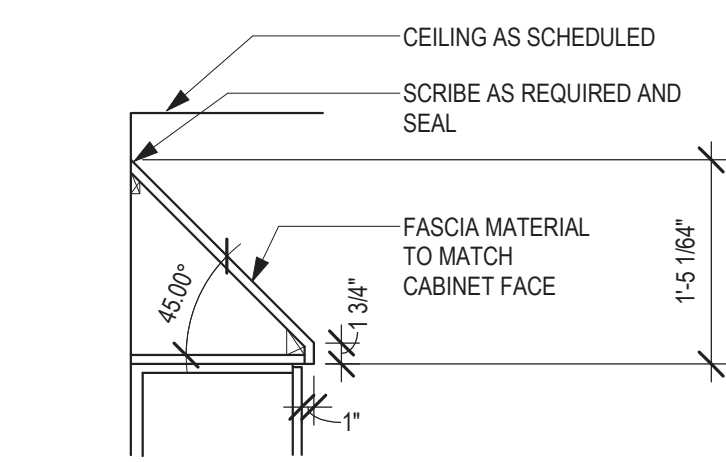


8 CASEWORK UPPER WITH SLOPED TOP
3/4" = 1'-0"

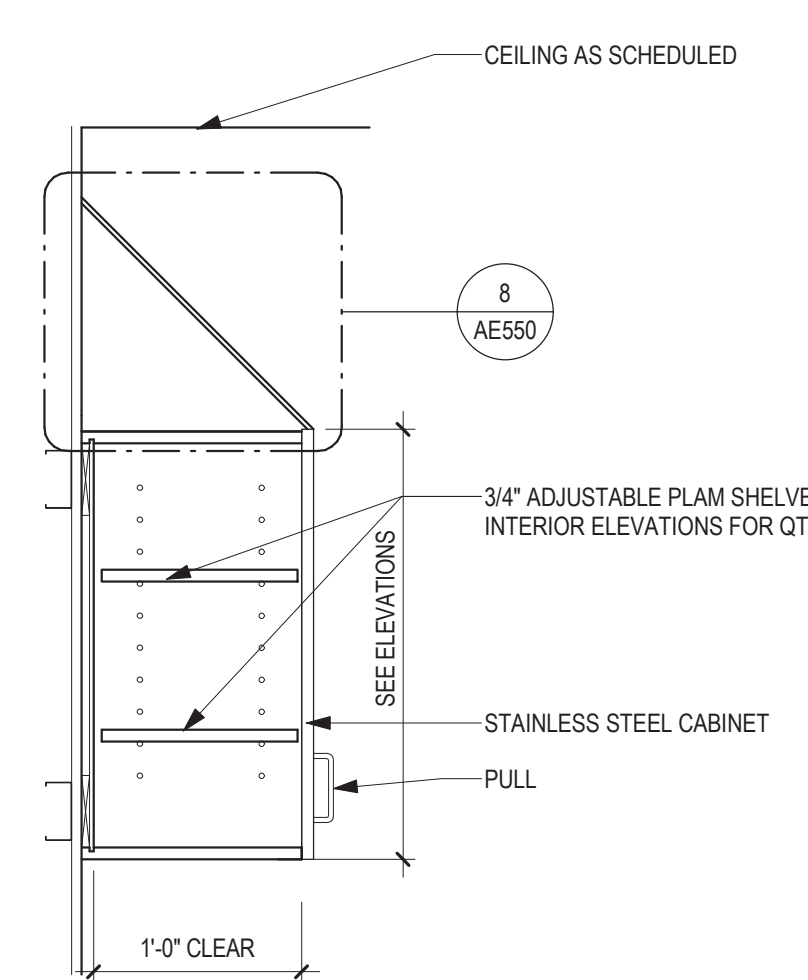


6 SECTION - STAINLESS STEEL WALL CABINET WITH DOOR
1" = 1'-0"

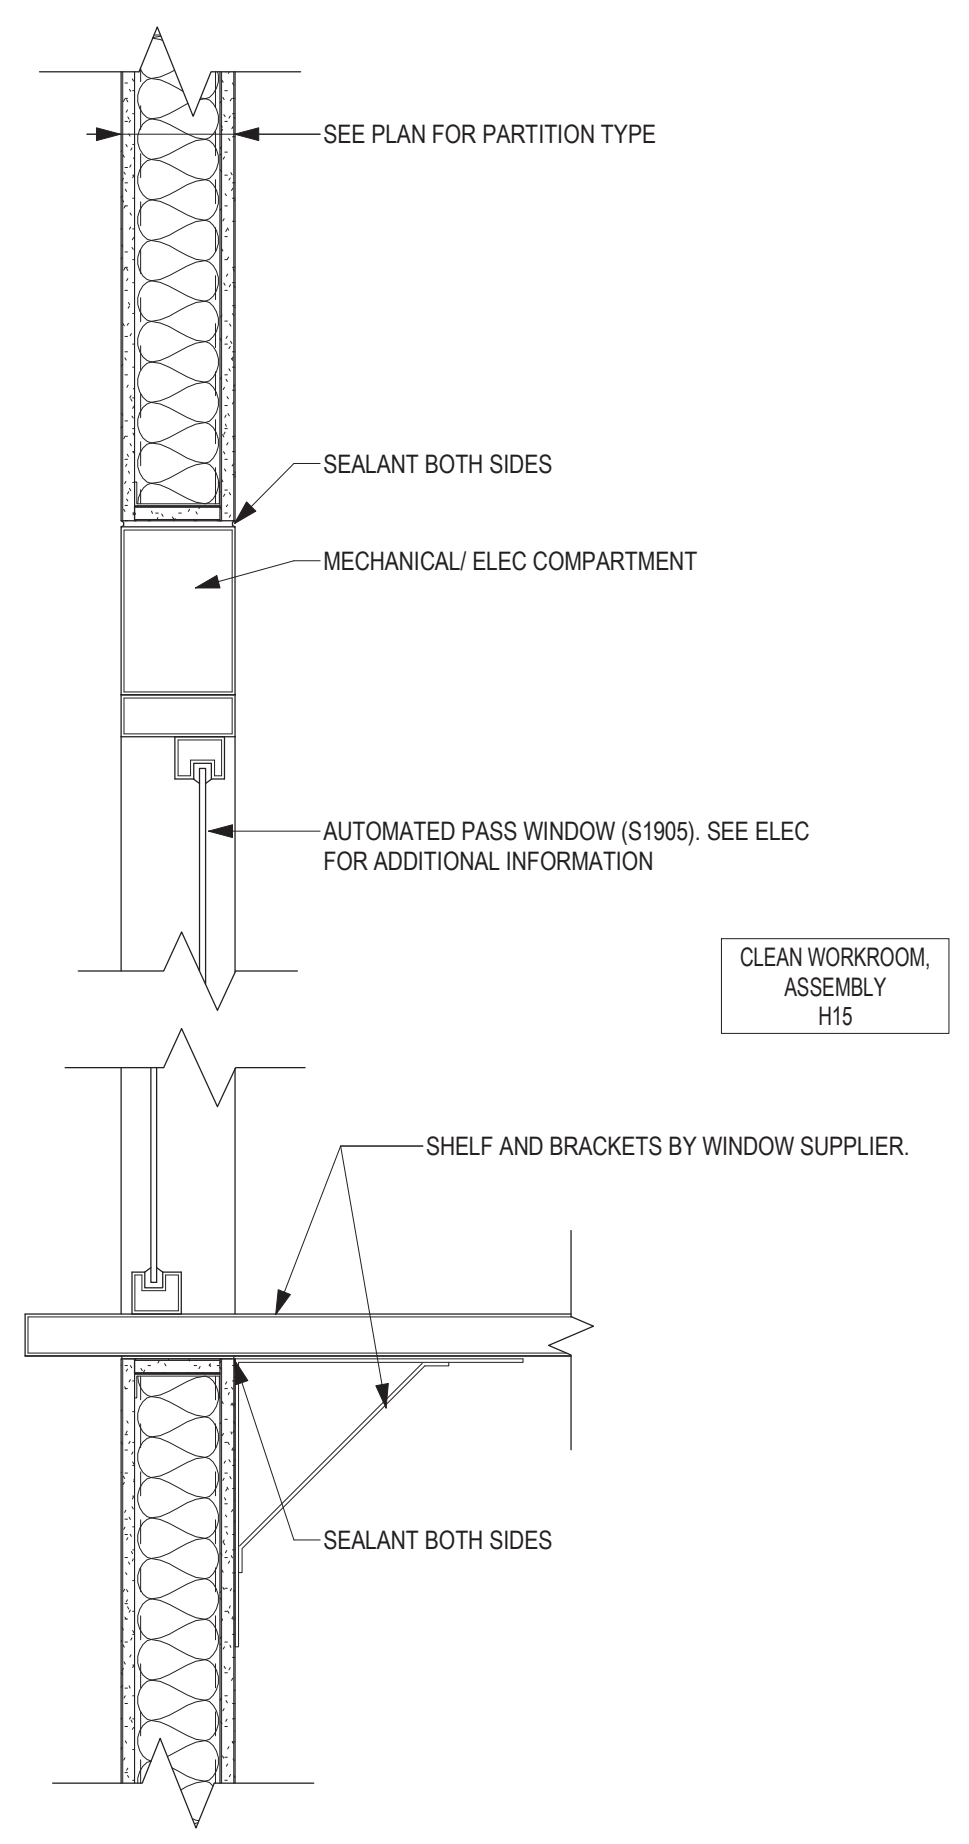


14 SECTION DETAIL - AUTOMATED PASS WINDOW
1 1/2" = 1'-0"

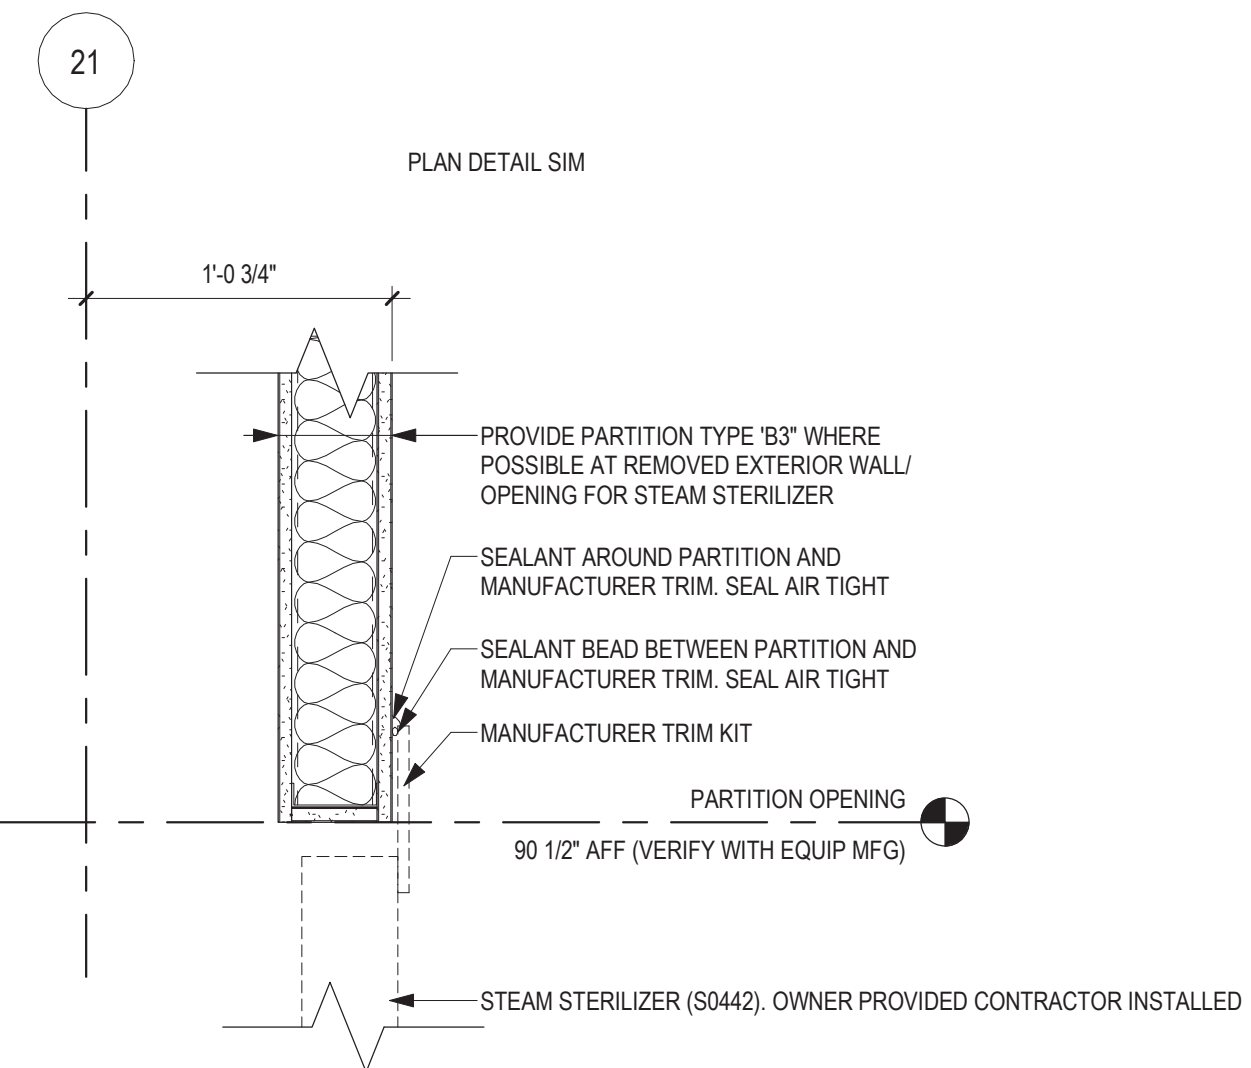

13 SECTION DETAIL - OPENING AT STEAM STERILIZER (TYP)
1 1/2" = 1'-0"

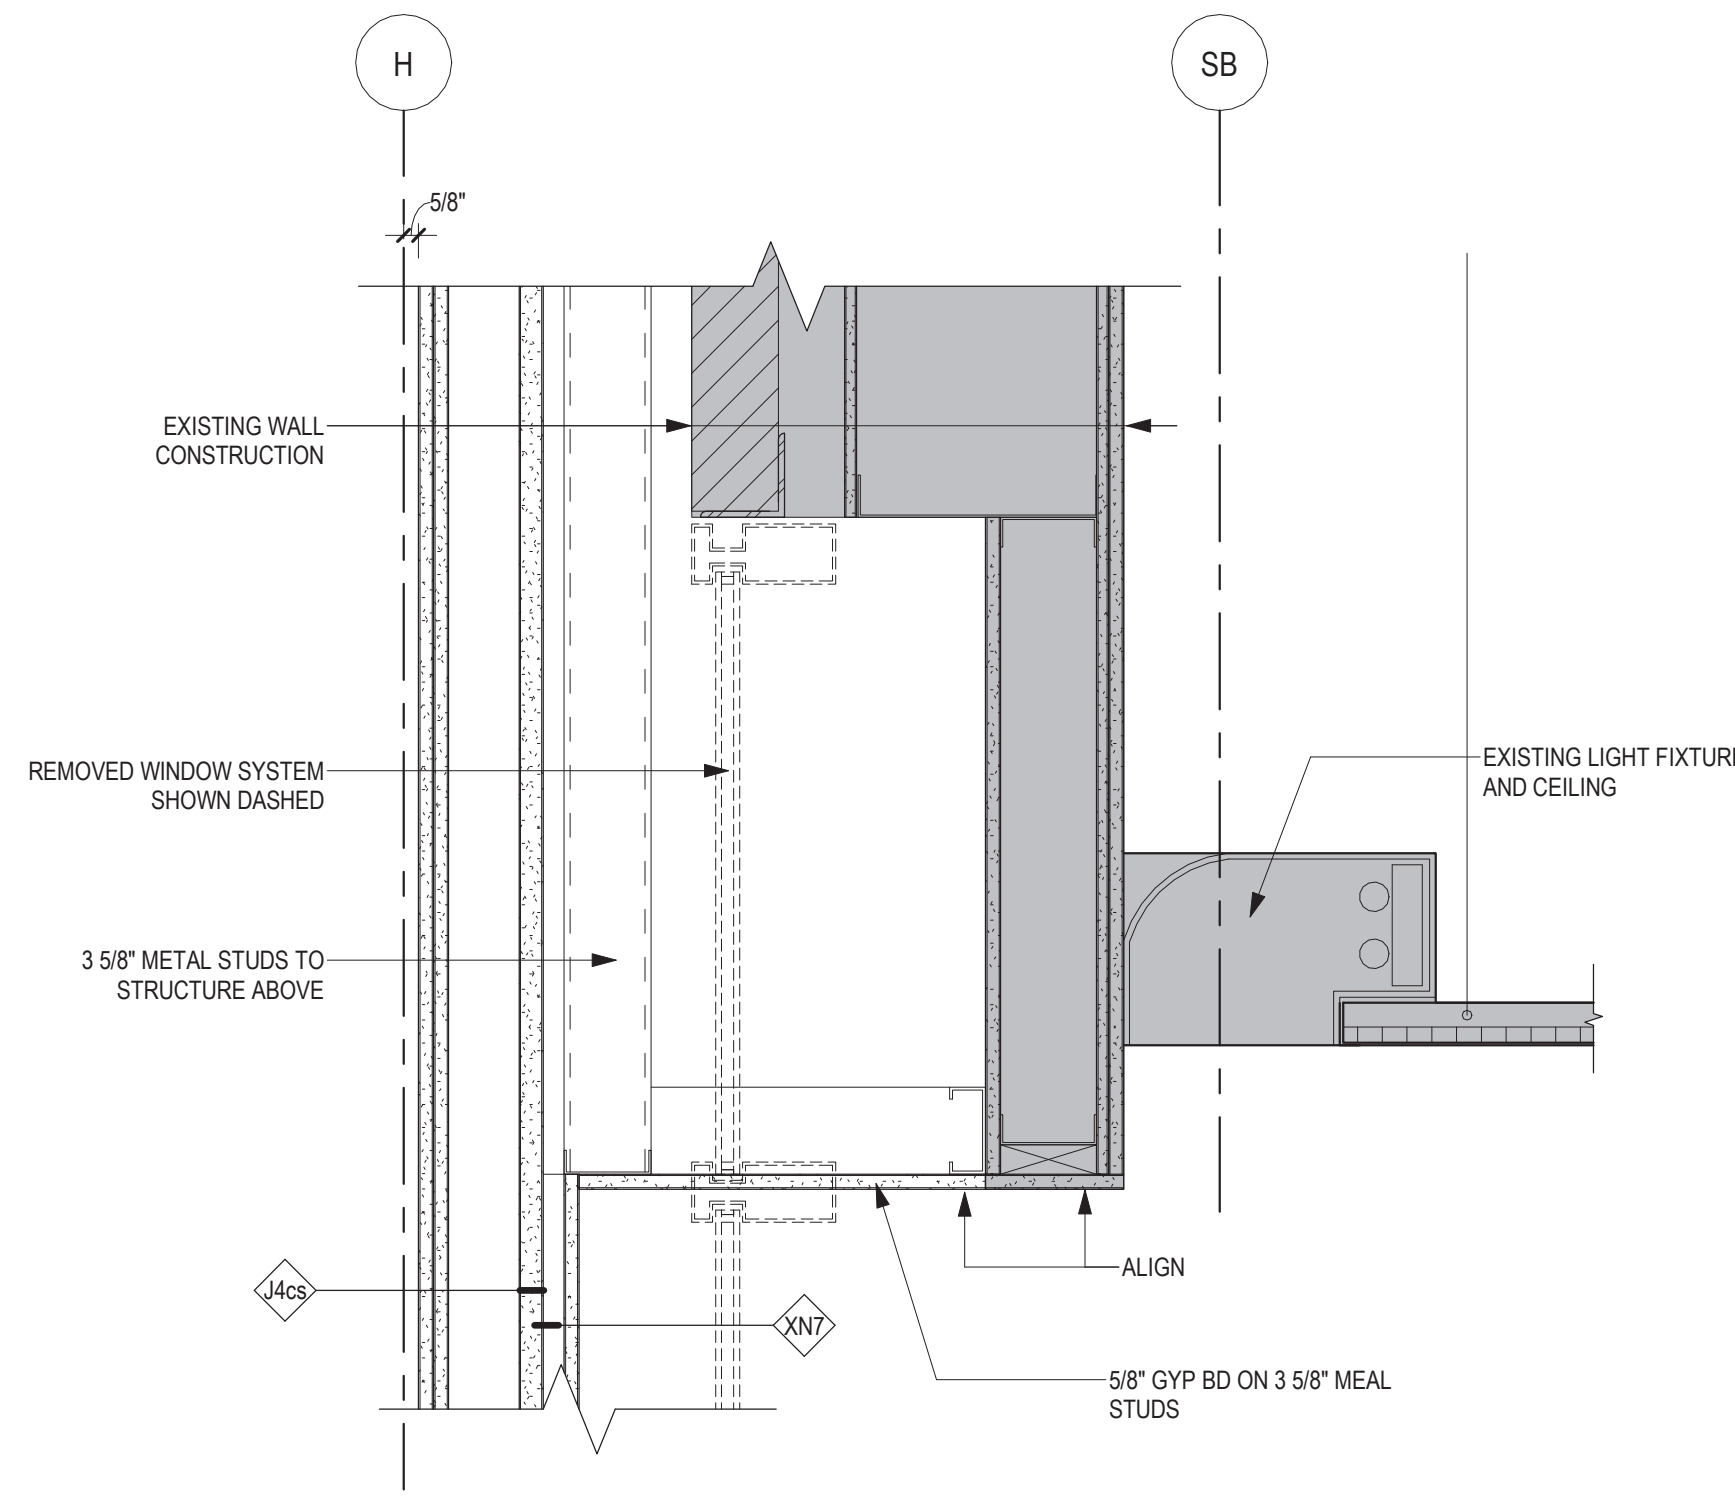

12 SECTION DETAIL - OPENING AT SURGERY / OR CORRIDOR
1 1/2" = 1'-0"

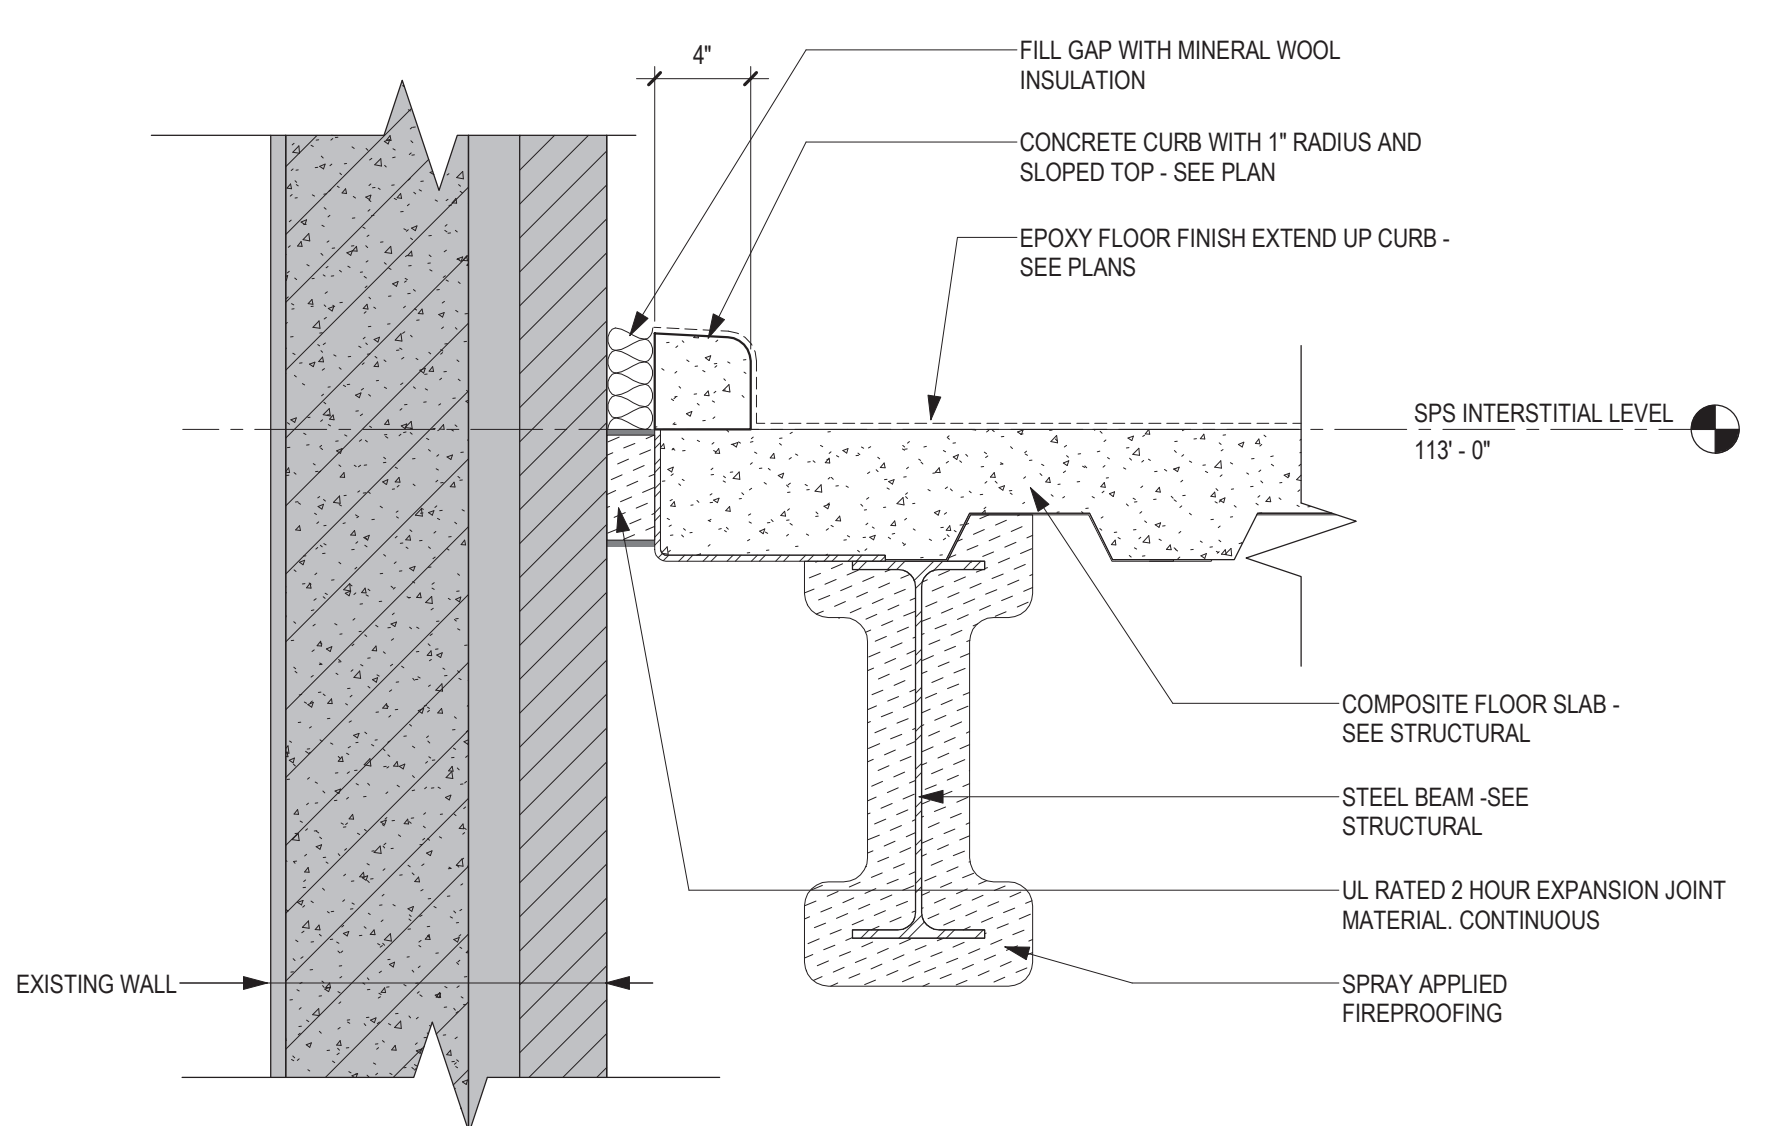

11 SECTION DETAIL - EXPANSION JOINT AT MECH ROOM (TYP)
1 1/2" = 1'-0"

Revisions:	Date:

CONSULTANT

IMEG

ARCHITECT/ENGINEER OF RECORD

ANDERSON

13605 1st Ave. N. #100 Plymouth, MN 55441
P 763.412.4000 | F 763.412.4090 | ae-mn.com
Anderson Engineering of Minnesota, LLC | Proj # 16584

Office of Construction and Facilities Management

VA U.S. Department of Veterans Affairs

Drawing Title

INTERIOR SECTION DETAILS

Approved:

Phase

BID DOCUMENTS

FULLY SPRINKLERED

Project Title

CONSTRUCT NEW SPS

Location
Sioux Falls, SD.

Issue Date
08/04/2022


Checked
Checker

Drawn
Author

Project Number
438-460

Building Number
5


Drawing Number
AE550

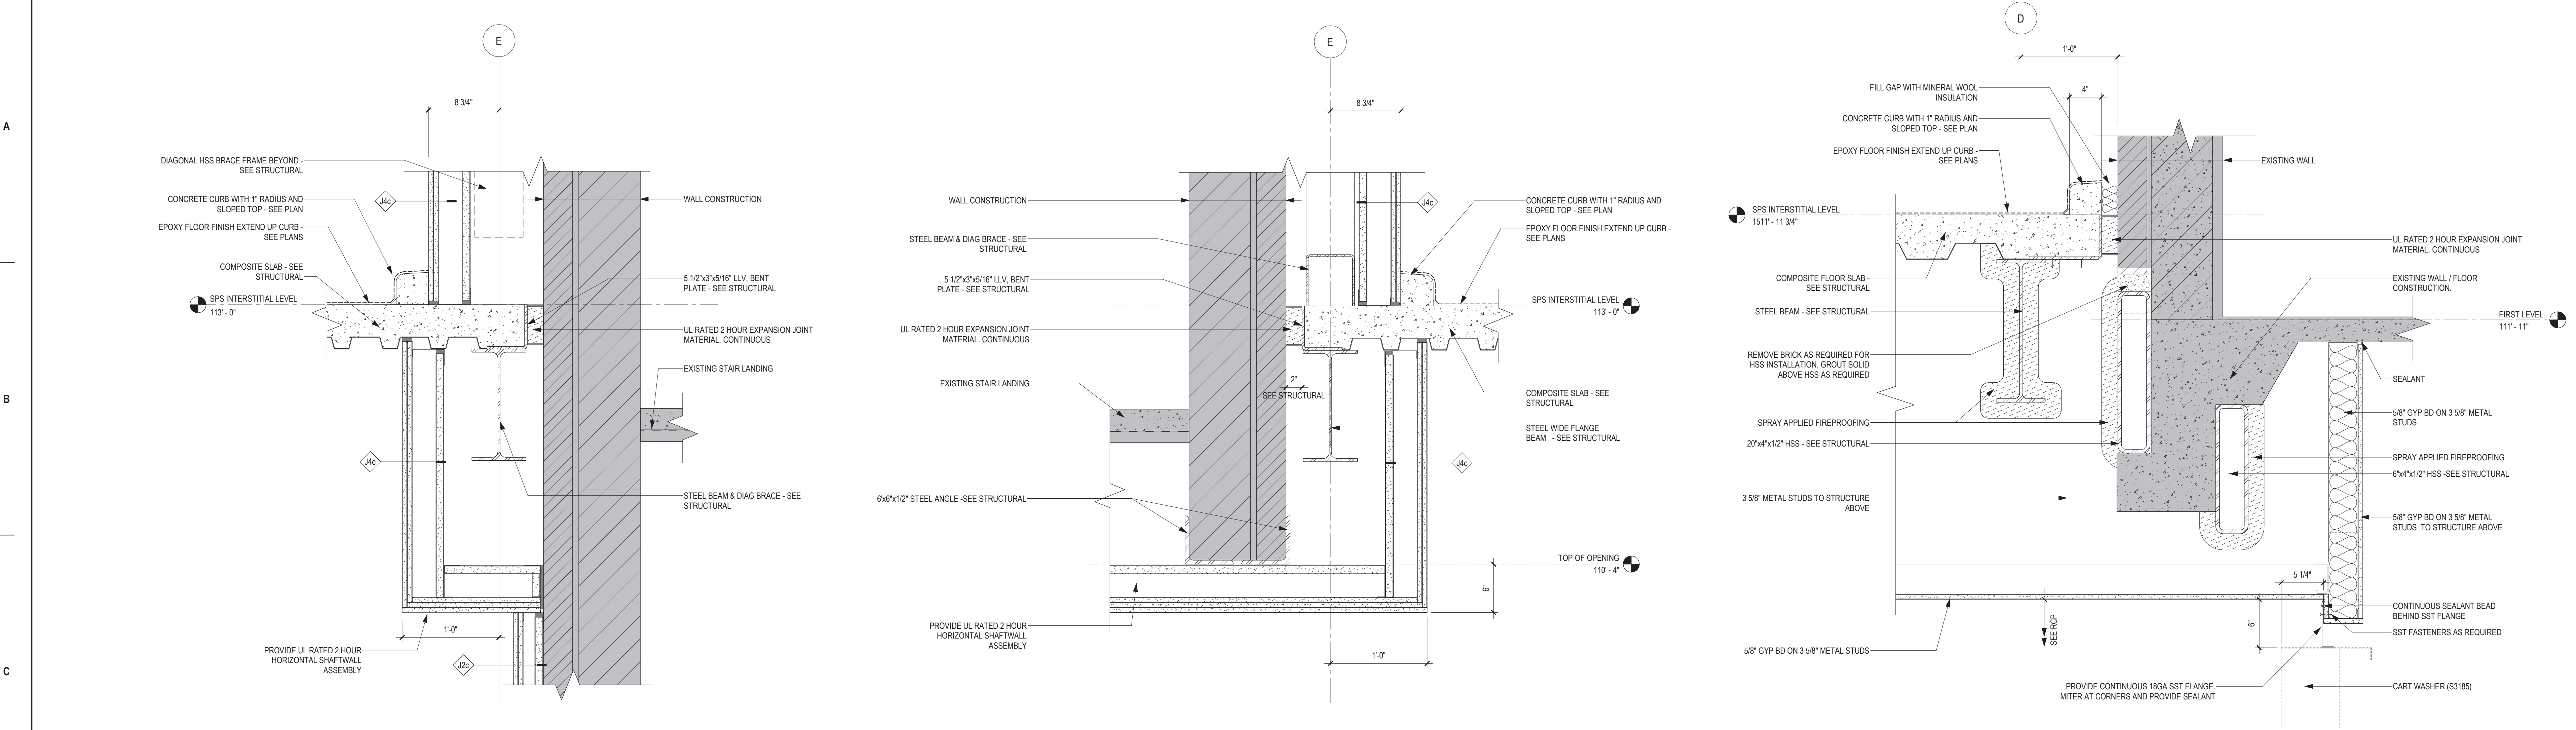

3 SECTION DETAIL - RATEED SOFFIT AT STEEL BEAM / BRACED FRAME 1 1/2" = 1'-0"

2 SECTION DETAIL - RATEED WALL AND SOFFIT AT EXISTING STAIR TOWER & BRACED FRAME 1 1/2" = 1'-0"

1 SECTION DETAIL - STEEL TUBE AND SOFFIT AT AUTOMATIC CART WASHER - H20B 1 1/2" = 1'-0"

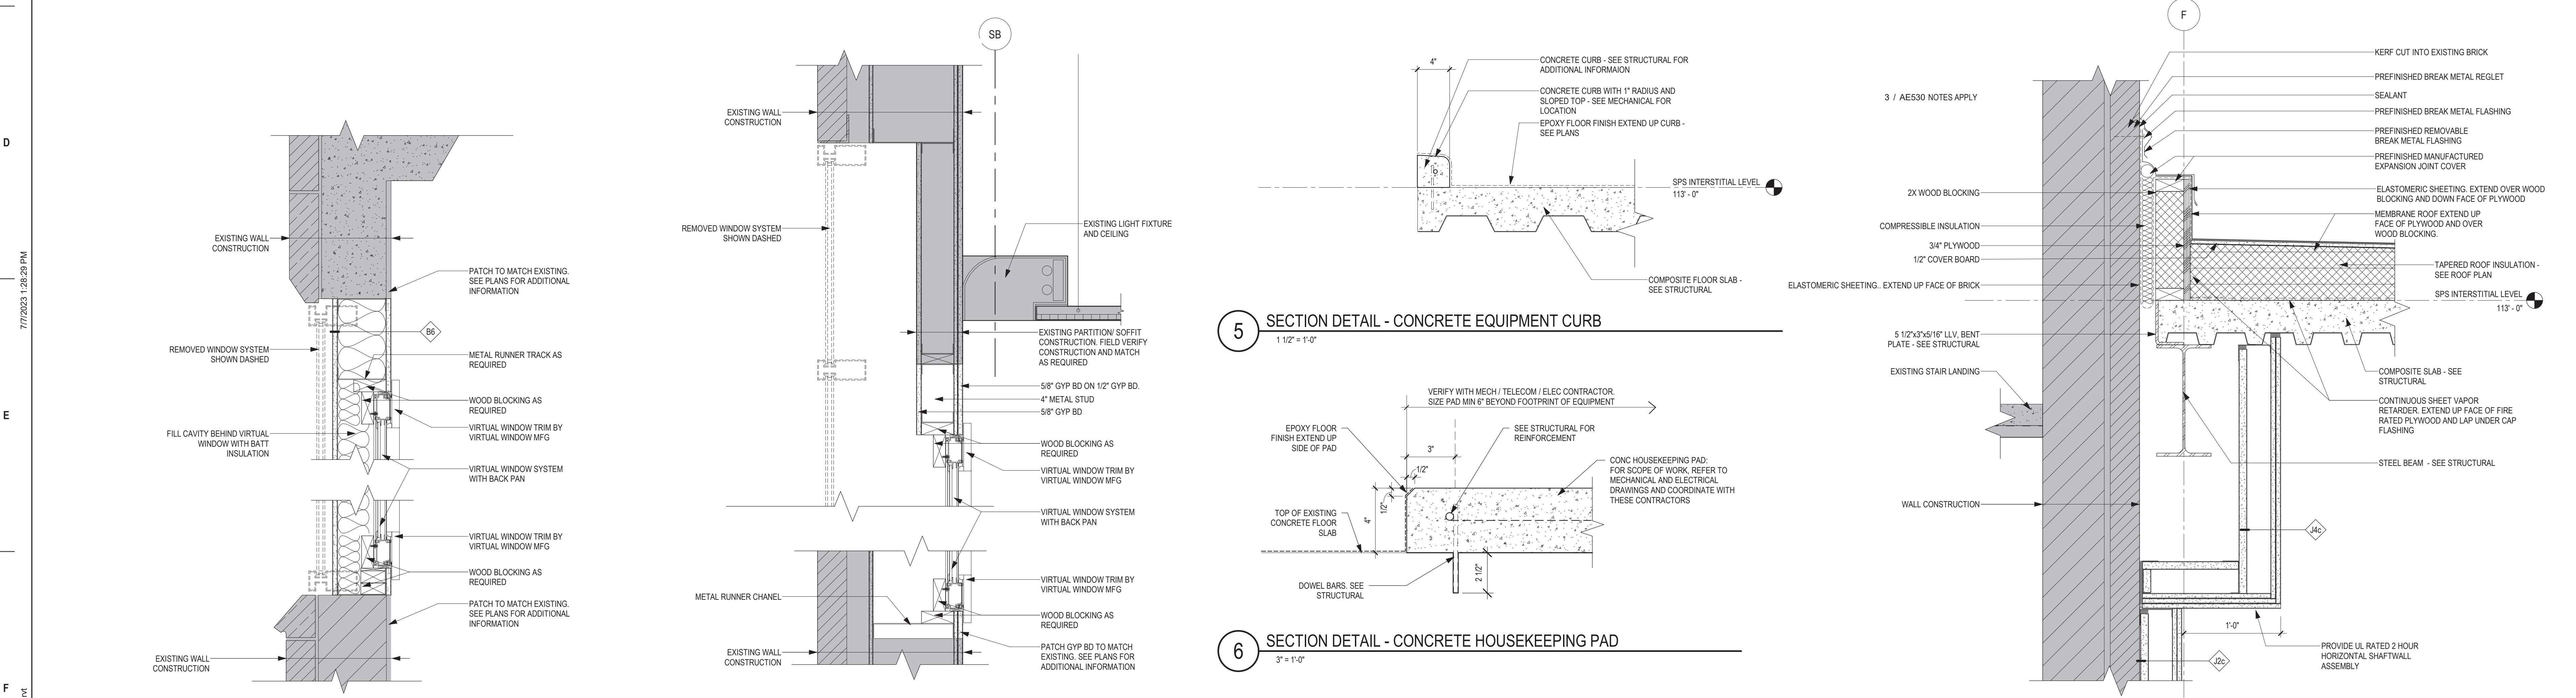

8 SECTION DETAIL - HEAD /SILL AT VIRTUAL WINDOW - FIRST LEVEL (TYP) 1 1/2" = 1'-0"

7 SECTION DETAIL - HEAD /SILL AT VIRTUAL WINDOW - SURGERY / OR CORRIDOR C43 1 1/2" = 1'-0"

6 SECTION DETAIL - CONCRETE EQUIPMENT CURB 1 1/2" = 1'-0"

5 SECTION DETAIL - CONCRETE HOUSEKEEPING PAD 1 1/2" = 1'-0"


4 SECTION DETAIL - RATEED SOFFIT AT STEEL BEAM & ROOF EXPANSION JOINT 1 1/2" = 1'-0"

Revisions:	CONSULTANT	ARCHITECT/ENGINEER OF RECORD	STAMP	Office of Construction and Facilities Management U.S. Department of Veterans Affairs	Drawing Title INTERIOR SECTION DETAILS	Phase BID DOCUMENTS	Project Title CONSTRUCT NEW SPS	Project Number 438-460		
	Date:	IMEG	ANDERSON						DATE: 08/04/2022 License # 9335	Approved:
							Issue Date 08/04/2022	Checked Checker	Drawn Author	Drawing Number AE551




1 1/2" = 1'-0"


Phase	Project Title			Project Number	
BID DOCUMENTS	CONSTRUCT NEW SPS			438-460	
				Building Number	
				5	
	Location			Drawing Number	
	Sioux Falls, SD.				
	Issue Date	Checked	Drawn	AE552	
FULLY SPRINKLERED	08/04/2022	Checker	Author		

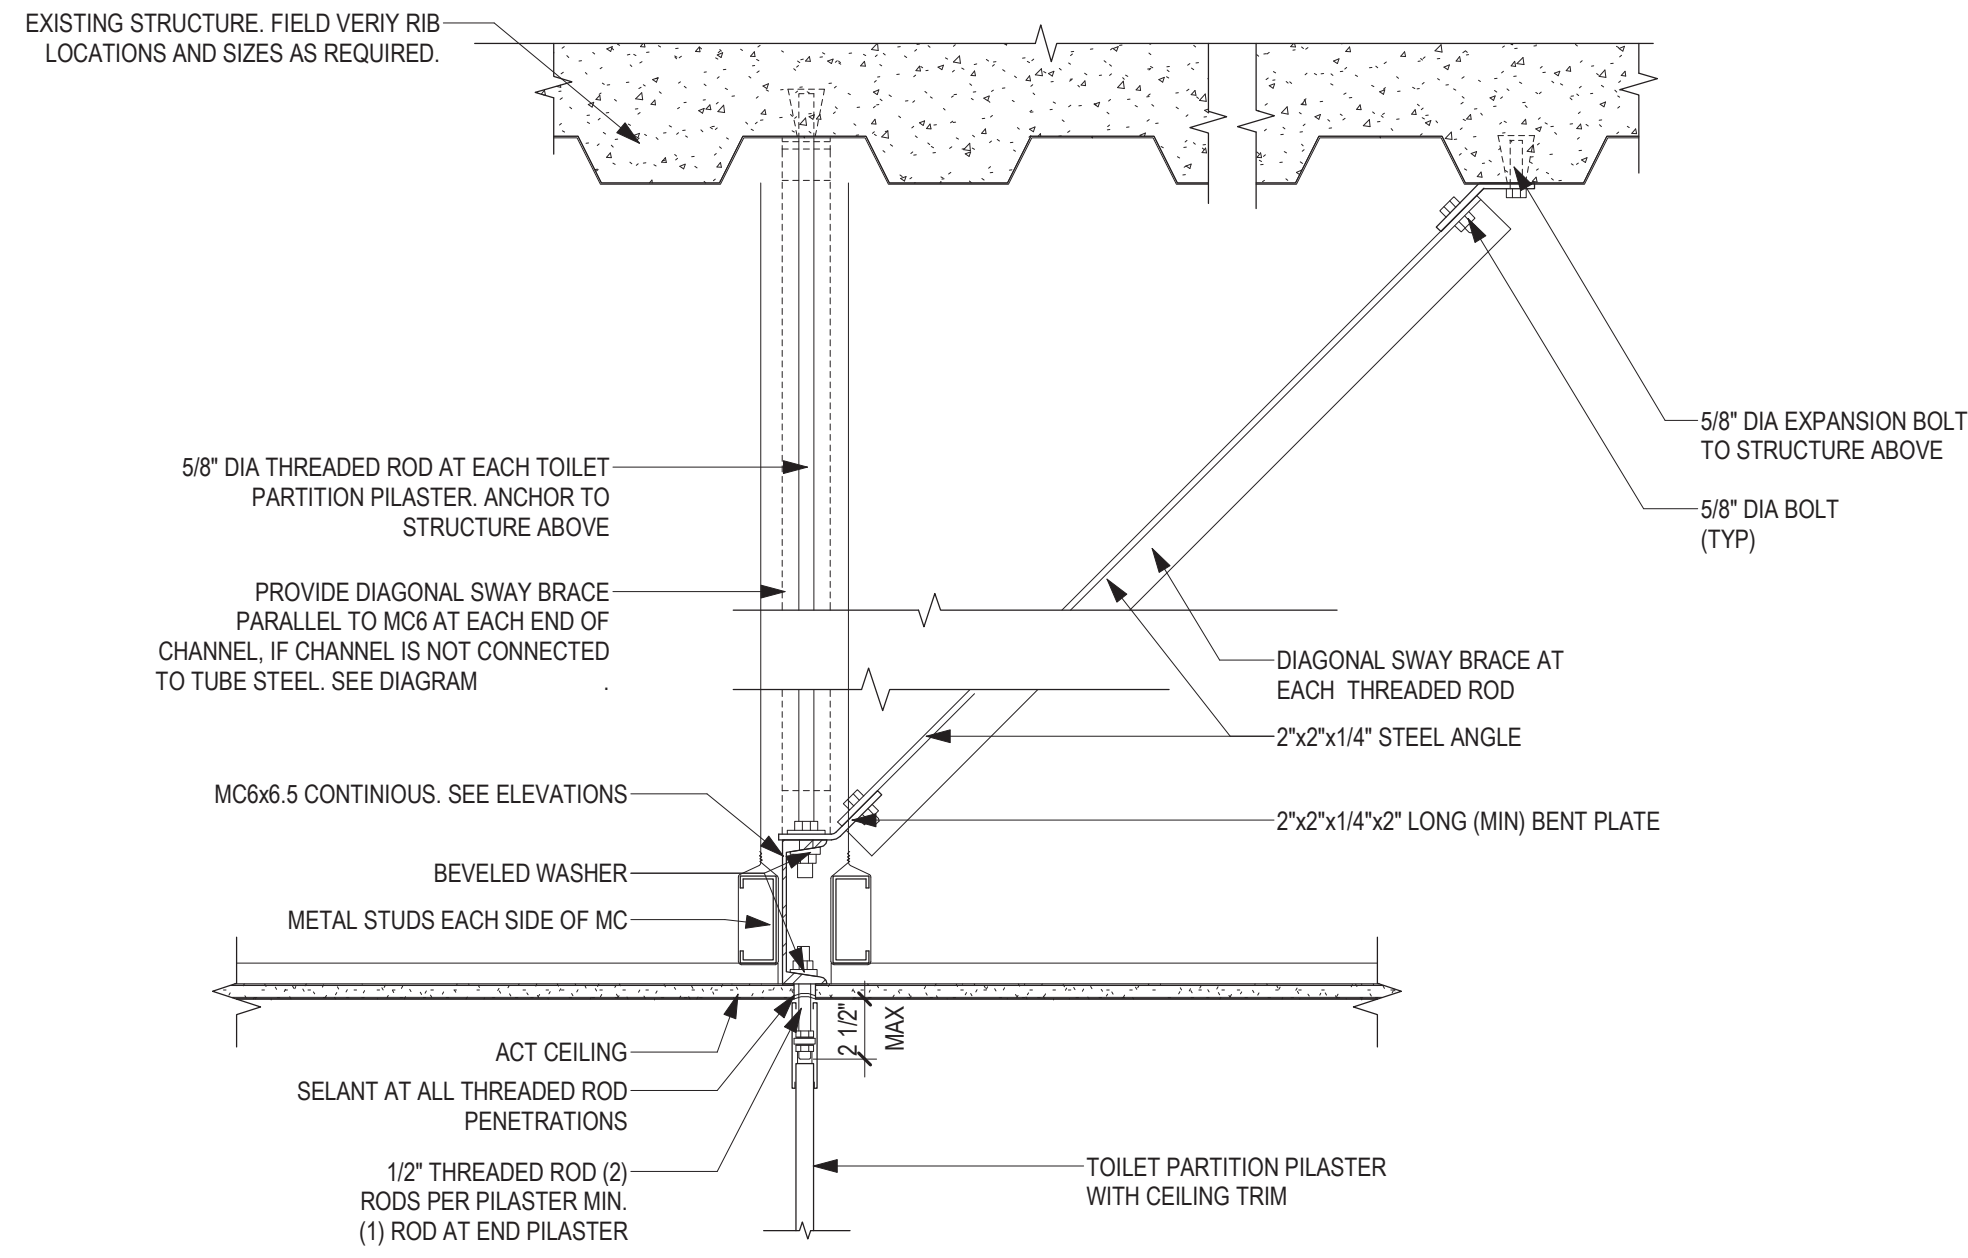


SECTION DETAIL - CEILING MOUNTED TOILET PARTITIONS
1 1/2" = 1'-0"

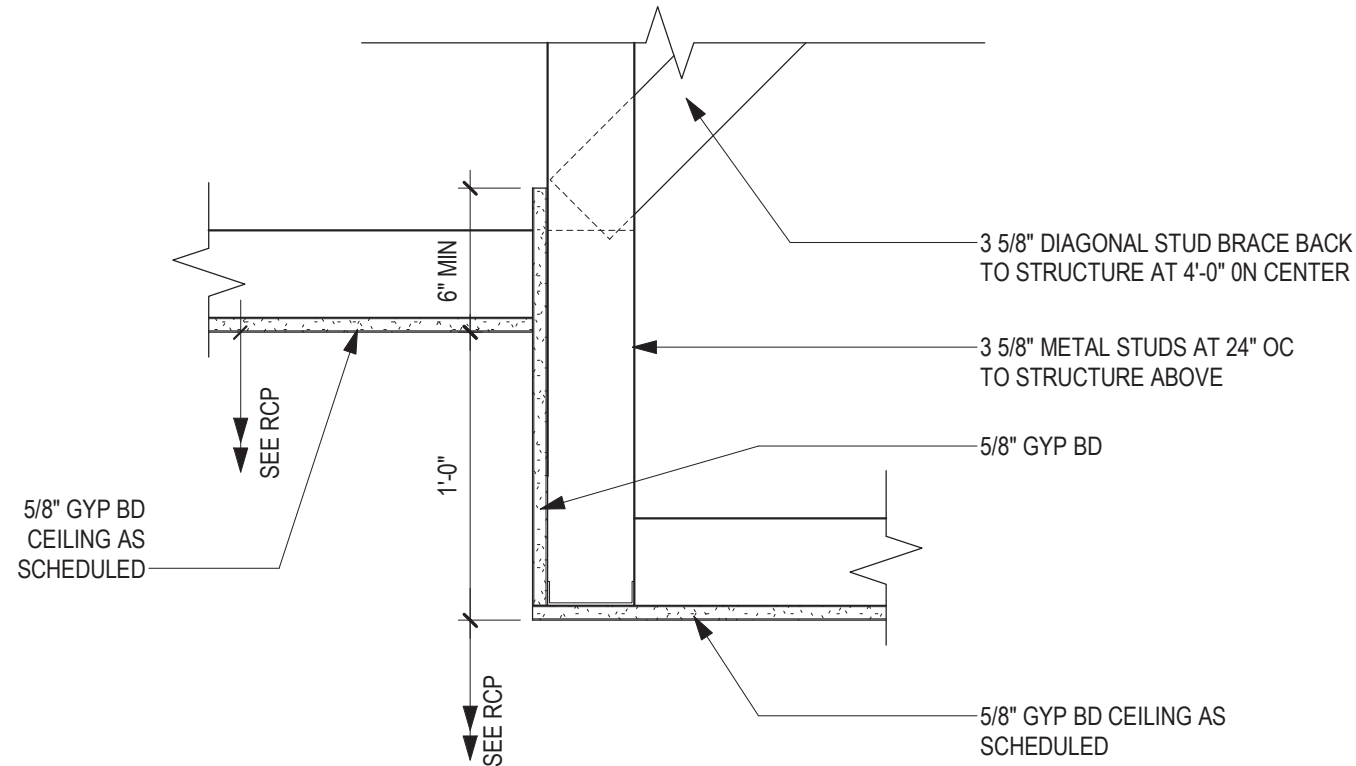


SECTION DETAIL - GYP BD TO GYP BD CEILING TRANSITION
1 1/2" = 1'-0"

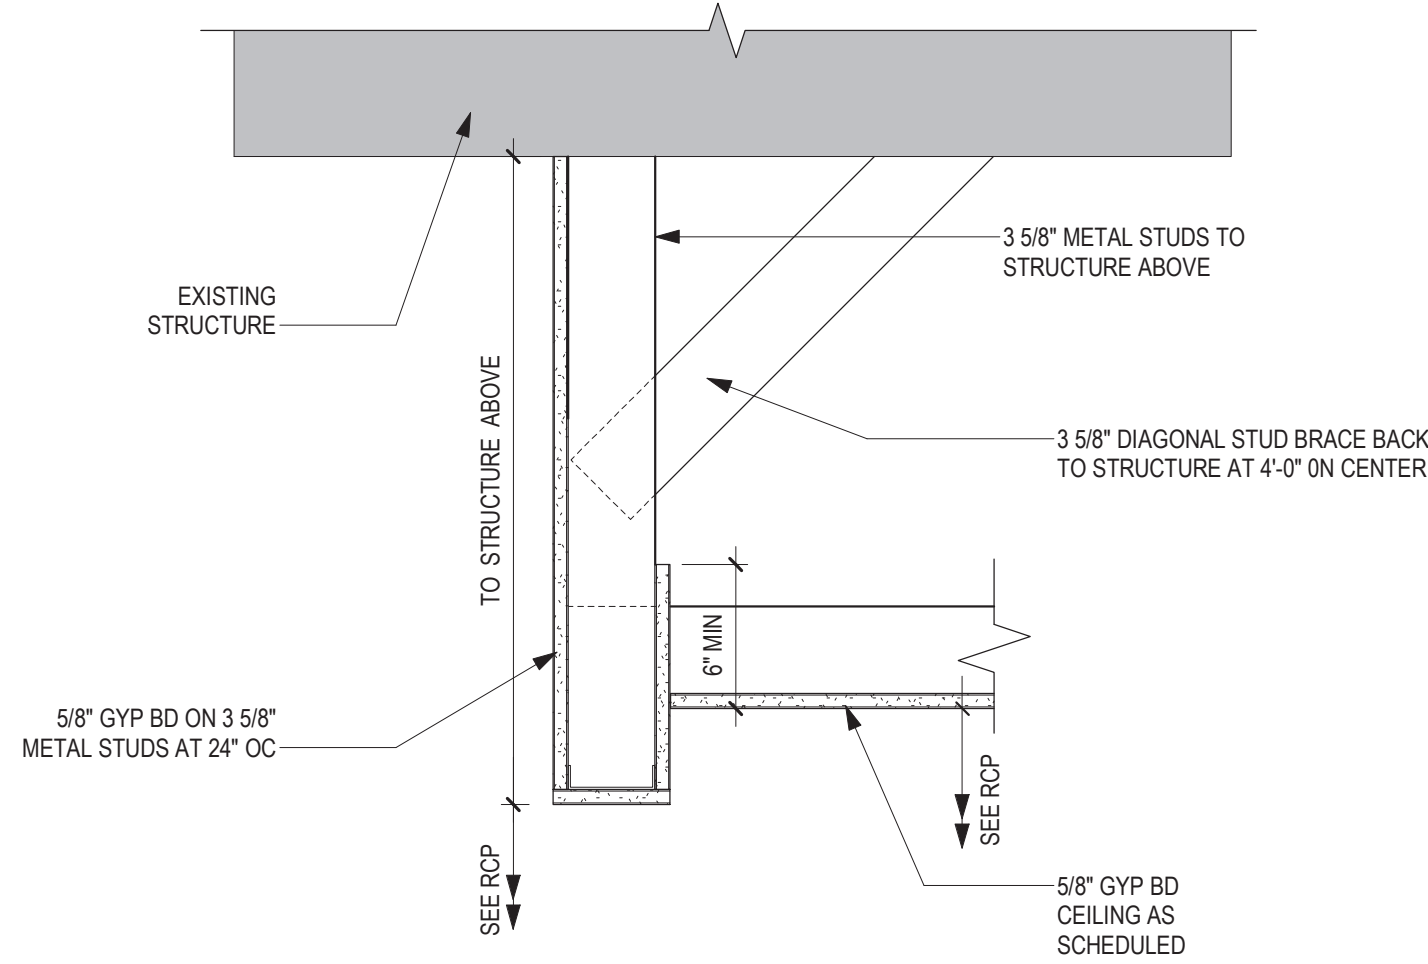

SECTION DETAIL - GYP BD RETURN
1 1/2" = 1'-0"

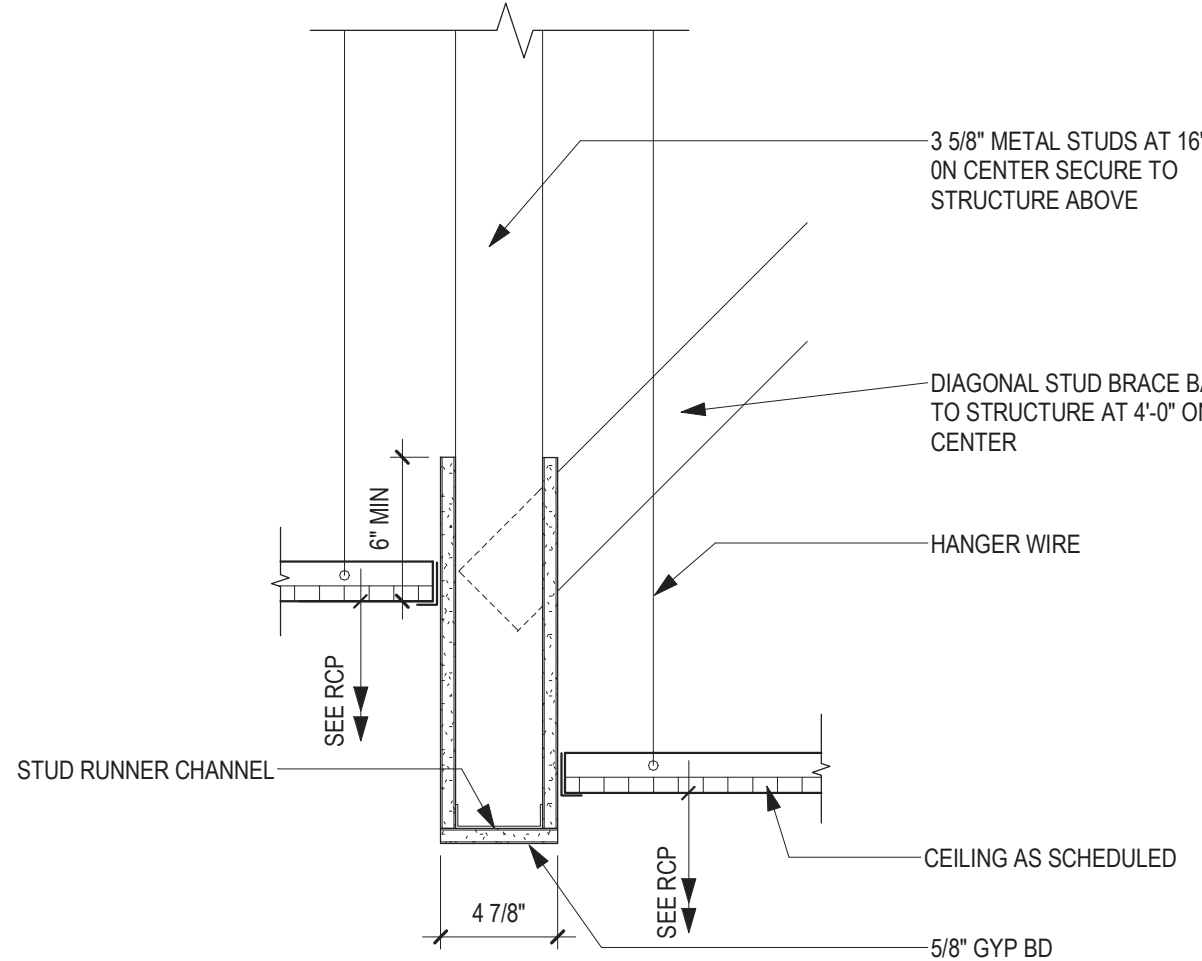

SECTION DETAIL - GYP BD BULKHEAD
1 1/2" = 1'-0"

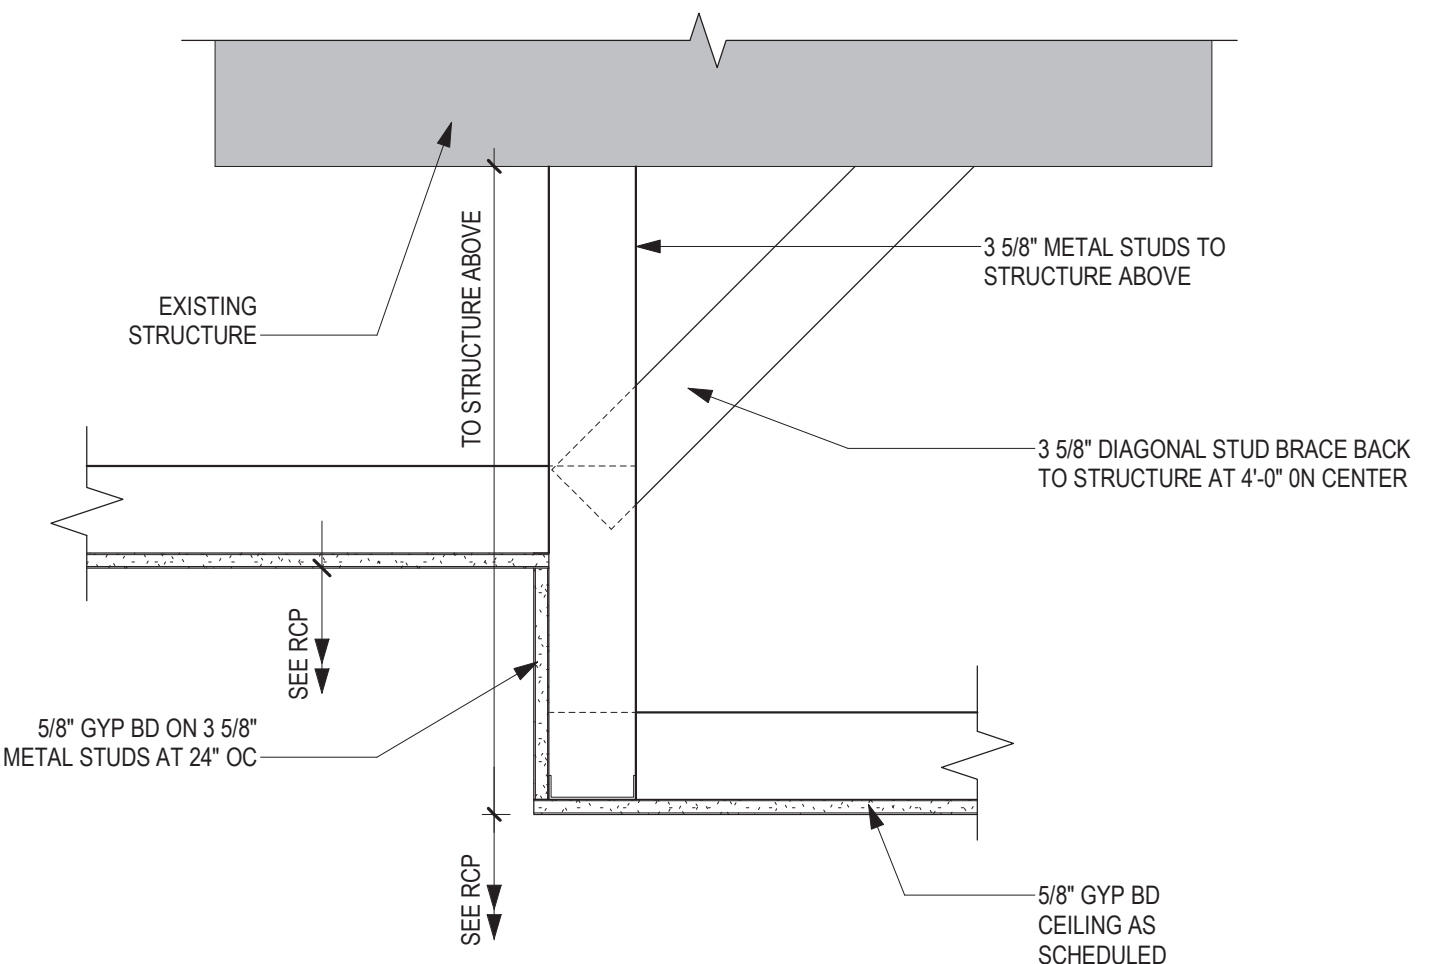

SECTION DETAIL - GYP BD CEILING TO GYP BD CEILING
1 1/2" = 1'-0"

Revisions:	Date:



ARCHITECT/ENGINEER OF RECORD

ANDERSON

13605 1st Ave. N. #100 Plymouth, MN 55441
P 763.412.4000 | F 763.412.4090 | ae-mn.com
Anderson Engineering of Minnesota, LLC | Proj # 16684

STAMP

Professional Engineer Seal for Thomas A. Olesak, State of Minnesota, License # 9335, dated 08/04/2022.

Office of Construction and Facilities Management

VA U.S. Department of Veterans Affairs

Drawing Title: CEILING DETAILS

Approved:

Phase: BID DOCUMENTS

FULLY SPRINKLERED

Project Title: CONSTRUCT NEW SPS

Location: Sioux Falls, SD.

Issue Date: 08/04/2022

Checked: Checker

Drawn: Author

Project Number: 438-460

Building Number: 5

Drawing Number: AE560

7/7/2023 1:28:35 PM
C:\Users\Public\Documents\Revit Projects\16584-RCT_gbarani@ae-mm.com.rvt
F
VA FORM 08 - 6231

A


B

C


D

E


F

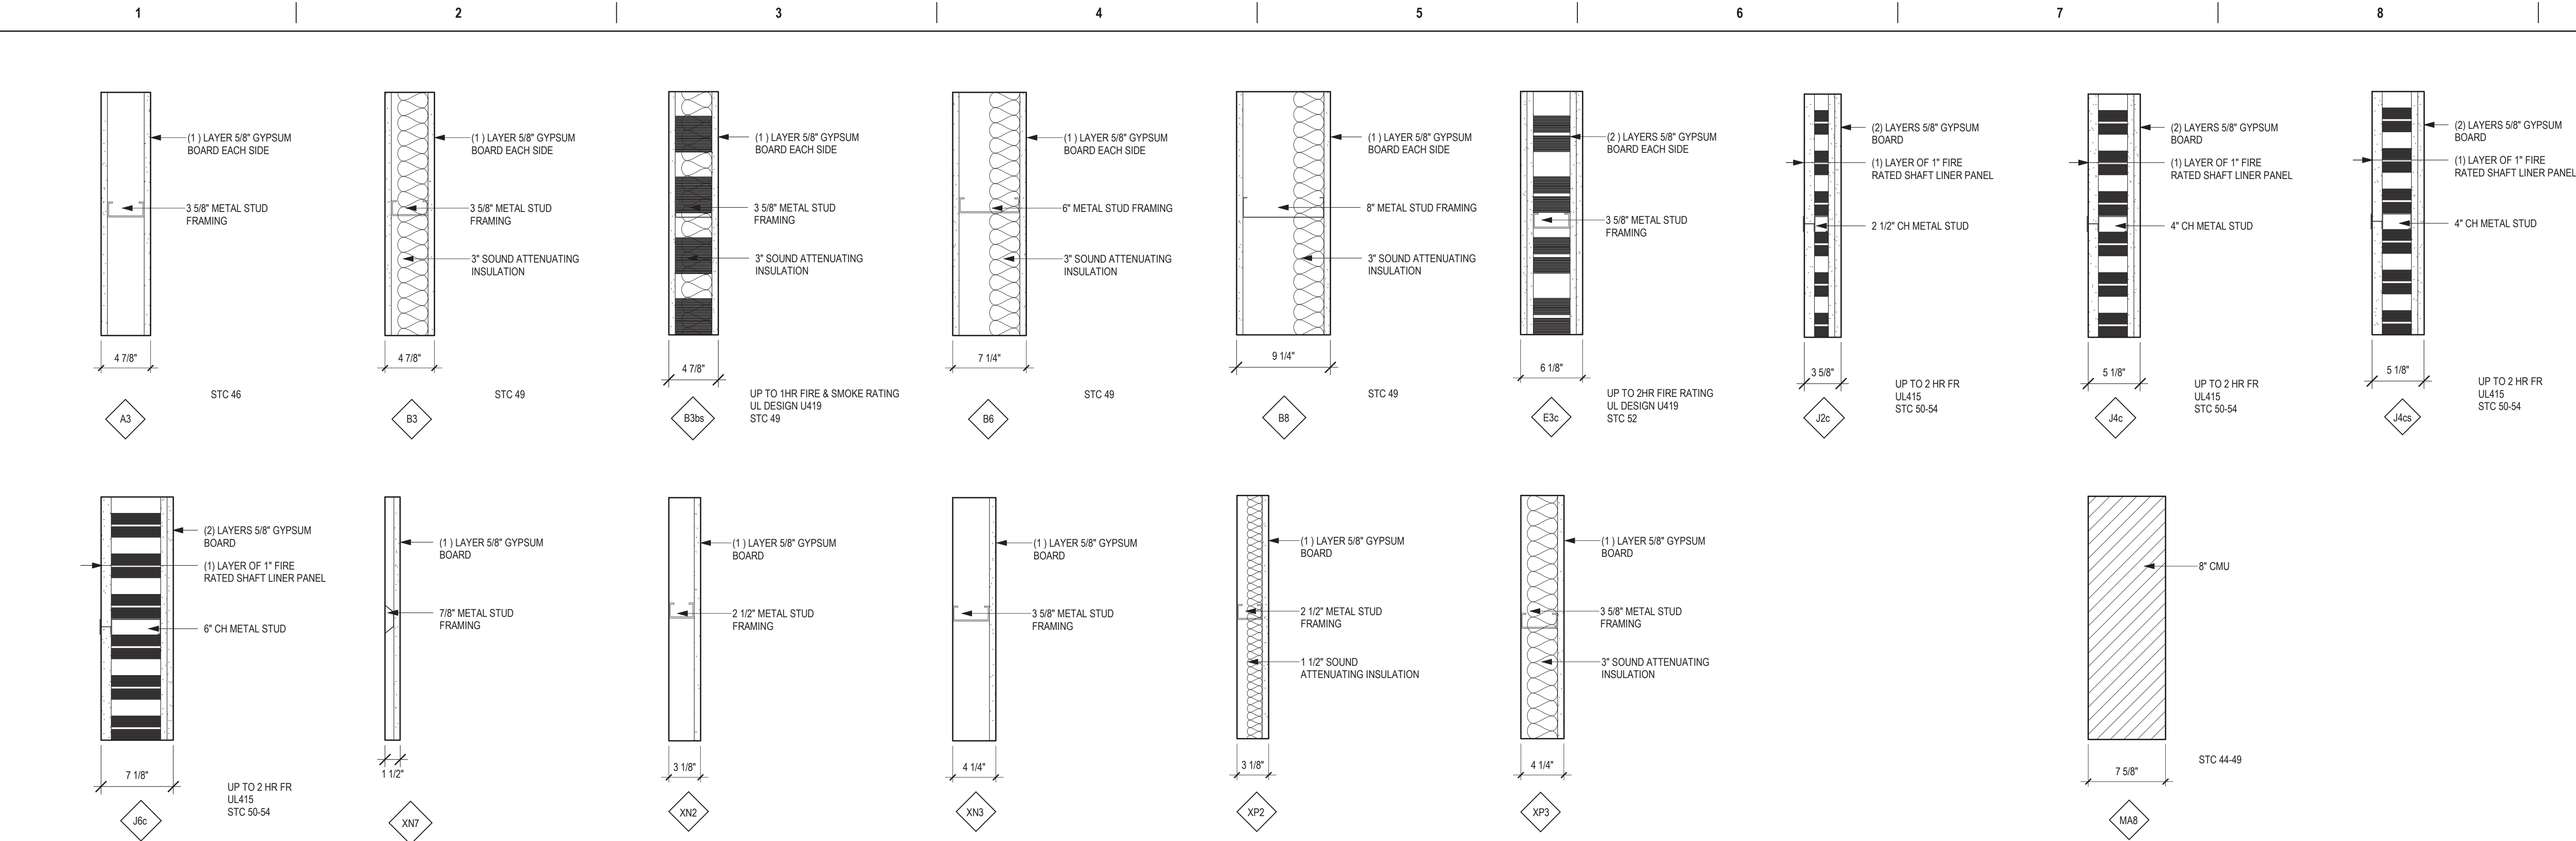


TYPES - PARTITION

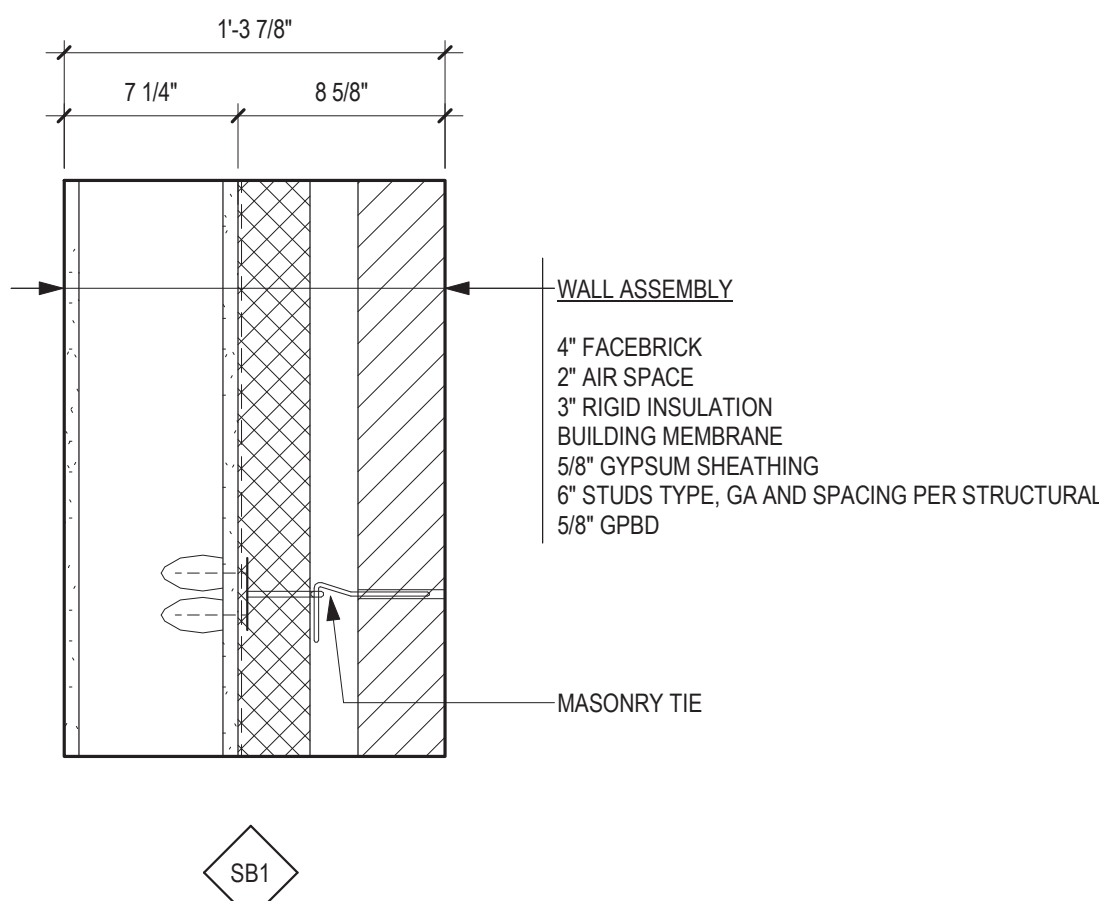

TYPES - WALL

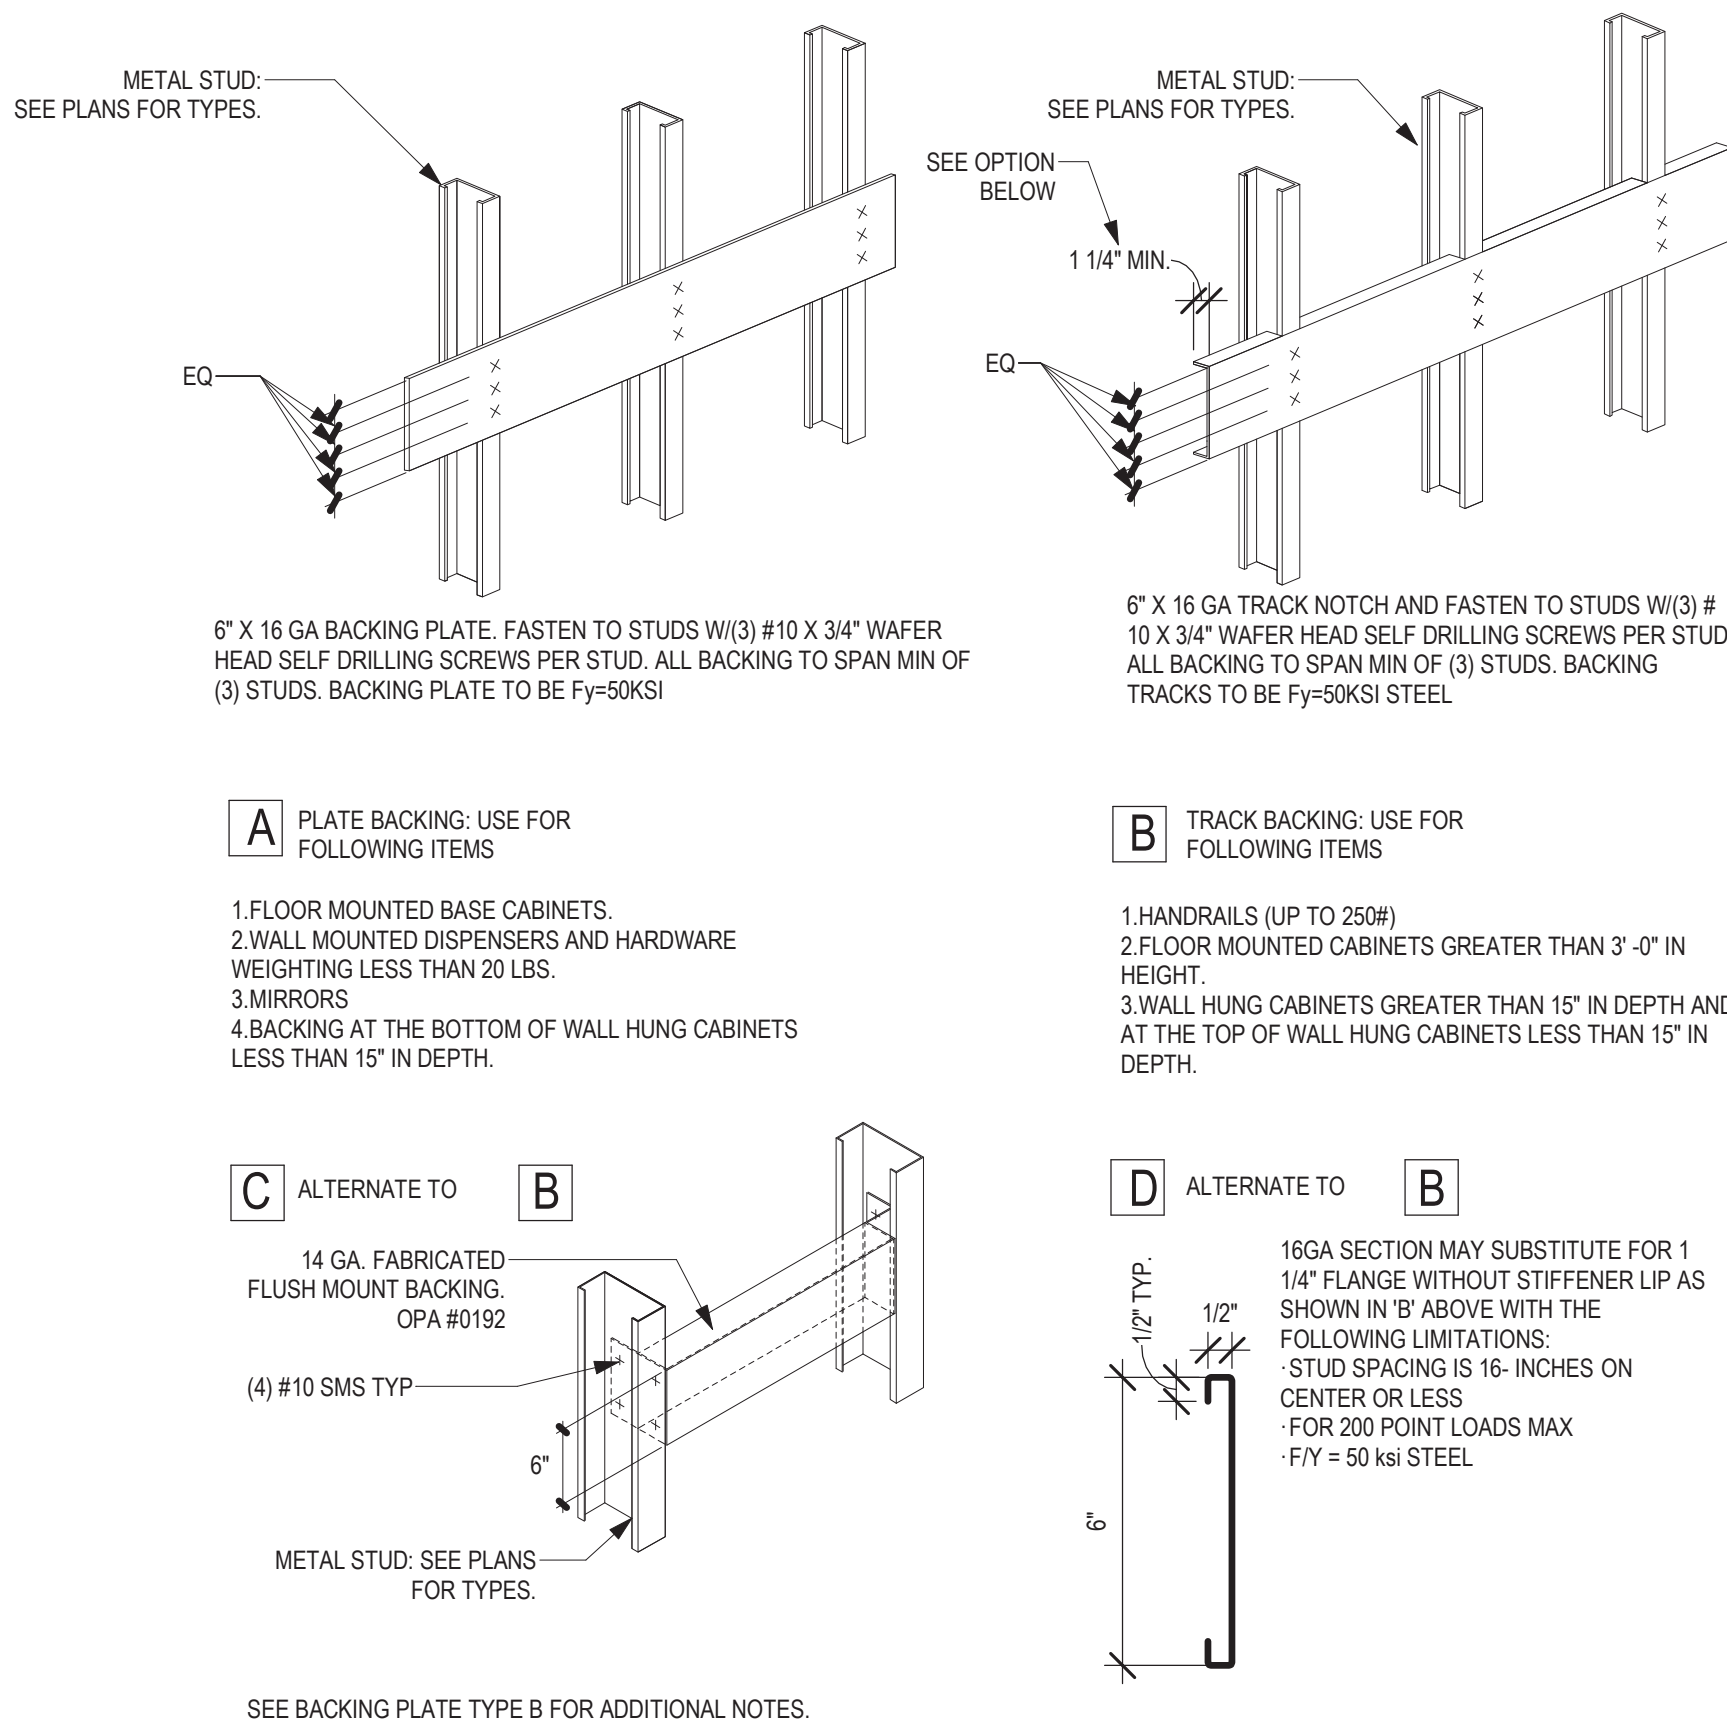


PARTITION BLOCKING-BACKING TYPES

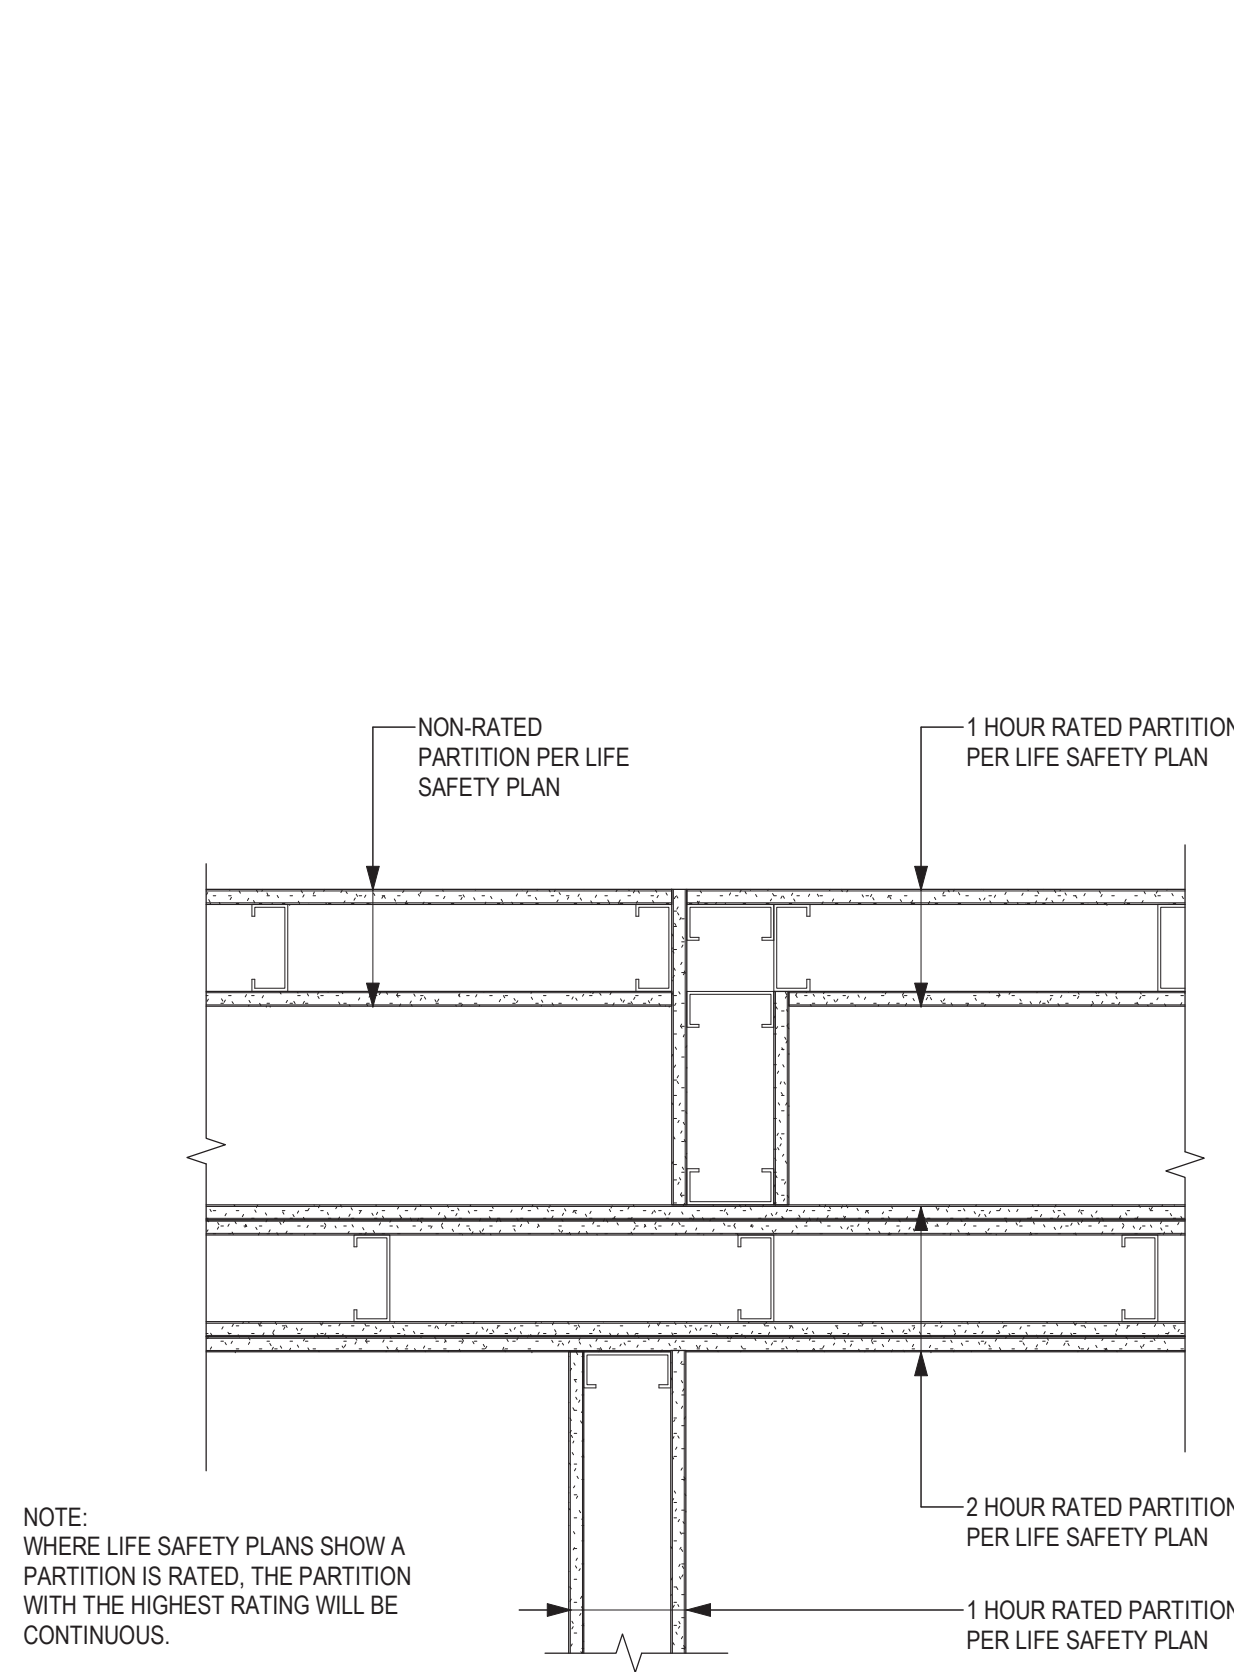

GUIDELINE - RATED WALL INTERSECTIONS

PARTITION GENERAL NOTES:

- SEE LIFE SAFETY PLANS FOR REQUIRED PARTITION FIRE RATINGS.
- GYPSUM BOARD AND METAL STUDS USED IN FIRE RATED SEPARATION PARTITIONS SHALL EXTEND FROM FLOOR TO UNDERSIDE OF STRUCTURE, UNLESS NOTED OTHERWISE.
- WHERE SMOKE PARTITIONS ARE REQUIRED BY LIFE SAFETY PLANS, THE FOLLOWING APPLIES TO ALL NON-ACoustical TYPE SMOKE PARTITIONS: EXTEND GYPSUM BOARD ON CORRIDOR SIDE TO STRUCTURE ABOVE. SEAL TOP AND BOTTOM OF PARTITION AND ALL PENETRATIONS THROUGH PARTITION ON CORRIDOR SIDE WITH A SMOKE SEALANT HAVING A MINIMUM WARM SMOKE TEMPERATURE OF 400 DEGREES FAHRENHEIT. ALL SEALS MUST HAVE PRE-APPROVAL OF CODE OFFICIAL. ROOM SIDE GYPSUM BOARD CAN EXTEND TO 6" ABOVE FINISHED CEILING.
- CONTRACTORS TO VERIFY CONDITIONS ABOVE CEILING AT EXISTING PARTITIONS IDENTIFIED WITH FIRE/SMOKE PARTITION SYMBOLS. REPAIR CONDITIONS THAT DO NOT MEET REQUIREMENTS OF THE INDICATED FIRE/SMOKE RATING SHOWN, SUCH AS BUT NOT LIMITED TO OPENINGS IN PARTITIONS, GAPS AROUND DUCTWORK, PIPES AND CONDUIT, MISSING SMOKE DAMPERS, ETC.
- DIMENSIONS TO METAL STUD PARTITION ARE MEASURED TO FINISH FACE OF PARTITION UNLESS NOTED OTHERWISE.
- THE DIMENSION SHOWING THE LOCATION OF A DOOR FRAME IN GYPSUM BOARD WALLS IS TO THE INSIDE OF THE DOOR FRAME (DOOR OPENING). PROVIDE 4" TYPICAL DIMENSION IF NO DIMENSION IS SHOWN.
- SOUND ATTENUATING INSULATION MEANS GLASS FIBER OR MINERAL WOOL BATTS OR BLANKETS BEARING THE UL LABEL FOR FIRE RESISTANCE. VERIFY TYPE AND DENSITY (PCF) WITH FIRE TEST NUMBER SHOWN ON PARTITION TYPE.
- FOR PARTITION HEIGHTS SEE PARTITION TAG LEGEND AND TAG SUBSCRIPTS ON PLANS.
- ALL FURRING TO BE PARTITION TYPE XP3. ALL PARTITIONS ARE TO BE PARTITION TYPE B3, UNLESS NOTED OTHERWISE.
- FOR PARTITION TYPES WITH GYPSUM BOARD ON ONE SIDE ONLY, INSTALL GYPSUM BOARD ON ROOM SIDE, UNLESS NOTED OR DETAILED OTHERWISE. FOR SHAFTWALL PARTITION TYPES, INSTALL LINER PANEL ON NON-ACCESSIBLE SIDE, UNLESS NOTED OR DETAILED OTHERWISE.
- PROVIDE 1/2" DEFLECTION SPACE AT THE TOP OF STUDS AT ALL PARTITIONS EXTENDING TO STRUCTURE, UNLESS NOTED OTHERWISE.
- WHEN GYPSUM BOARD PARTITIONS ARE LOCATED BELOW STRUCTURE THAT HAS A VERTICAL DEFLECTION MOVEMENT MORE THAN 1/2" PROVIDE PARTITION HEADS WITH VERTICAL MOVEMENT CAPABILITY TO MATCH THAT DEGREE OF MOVEMENT. MAINTAIN THE REQUIRED FIRE RATING OF FIRE RATED PARTITIONS FROM FLOOR TO STRUCTURE ABOVE WITH FIRE TESTED HEAD CONSTRUCTION.
- WHEN PARTITION FRAMING RUNS HIGHER THAN 12'-0" ABOVE FINISH FLOOR, BRACE PARTITION BACK TO STRUCTURE ABOVE WITH METAL STUDS EVERY 4'-0" ON CENTER MINIMUM.
- BULKHEAD FRAMING SHALL EXTEND TO UNDERSIDE OF STRUCTURE WITH DIAGONAL STUD FRAMING BRACES AT 4'-0" ON CENTER (2 BRACES MINIMUM) WITH GYPSUM BOARD EXTENDING 6" ABOVE CEILING MINIMUM, UNLESS NOTED OTHERWISE.
- GENERAL CONTRACTOR SHALL PROVIDE AND COORDINATE ALL IN-WALL BLOCKING FOR WALL MOUNTED CASEWORK AND EQUIPMENT SUPPLIED BY THIS CONTRACT. OWNER FURNISHED OR BY VENDORS. CONTRACTORS OPTION TO PROVIDE 3/4" FIRE TREATED PLYWOOD OR SHEET METAL BLOCKING FOR WALL MOUNTED EQUIPMENT, CASEWORK, DOOR STOPS, ACCESSORIES, ETC, UNLESS NOTED OTHERWISE.
- IN WET AREAS SUCH AS BUT NOT LIMITED TO SHOWER, TUB, GLASS WASHING ROOMS, SOILED UTILITY ROOMS, JANITOR CLOSETS, COMMERCIAL FOOD PROCESSING ROOMS, ETC, USE TILE BACKER BOARD BEHIND THE CERAMIC TILE AND EXTEND TO 2'-0" BEYOND ALL SIDES OF THE PLUMBING FIXTURE. IN DOUBLE LAYER WALLS WHERE THE TILE BACKER BOARD IS INSTALLED OVER A BASE LAYER OF GYPSUM BOARD, APPLY A WATER BARRIER (BUILDING WRAP) NOT A VAPOR RETARDER, OVER THE BASE LAYER OF GYPSUM BOARD. IN HIGH HUMIDITY AREAS SUCH AS SAUNAS, STEAM ROOMS AND SWIMMING POOLS, WHERE WALLS ARE EXPOSED TO CONSTANT MOISTURE, USE TILE BACKER BOARD BEHIND CERAMIC TILE.
- IN WET AREAS SUCH AS SOILED UTILITY ROOMS, JANITOR CLOSETS, ETC, USE 5/8" WATER RESISTANT GYPSUM BOARD OR 5/8" FR WATER RESISTANT GYPSUM BOARD.
- FOR ALL REMODELING PROJECTS, ALL PARTITIONS NOTED AT INFILLS WITHIN, OR EXTENSIONS ONTO EXISTING PARTITIONS, ARE NOTED AS SUCH FOR INTENT ONLY. ALL EXPOSED PARTITION FACES ARE TO ALIGN.

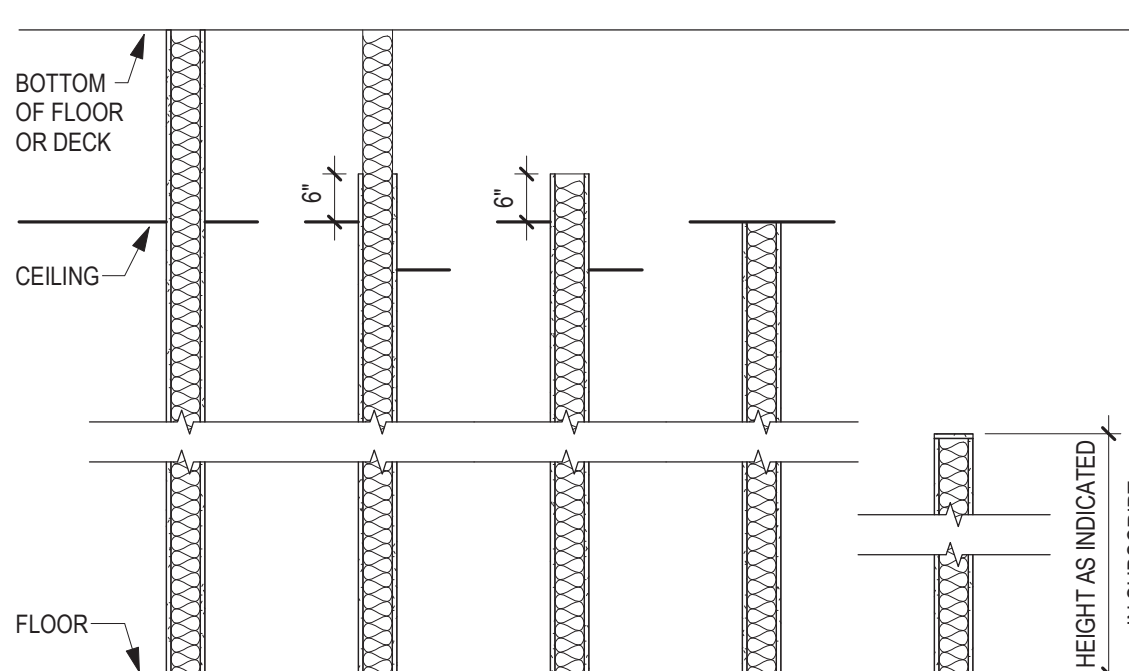

- GENERAL NOTES:
- FOR PARTITIONS WITH UNEQUAL LAYERS OF GYPSUM BOARD ON EACH SIDE, THE SIDE OF THE PARTITION WITH THE TAG INDICATES WHERE THE EXTRA LAYER(S) OF GYPSUM BOARD ARE TO BE INSTALLED. REFER TO PARTITION TYPES FOR MORE INFORMATION.
 - DIMENSIONS TO METAL STUD PARTITIONS ARE MEASURED TO FINISH FACE UNLESS NOTED OTHERWISE.
 - AT INFILL WITHIN OR EXTENSIONS ONTO EXISTING PARTITIONS, THE PARTITION TAG NOTED FOR INTENT ONLY. FINISHED PARTITION FACES ARE TO ALIGN WITH ADJACENT EXISTING PARTITION FACES.
 - SUBSCRIPTS MAY BE USED WITH ANY PARTITION TYPE.
- NO SUBSCRIPT (D) SUBSCRIPT (C) SUBSCRIPT (U) SUBSCRIPT (X-X') SUBSCRIPT
EXTEND ENTIRE BECK, EXTEND PARTITION TO 6" PARTITION TO FINISHED UNDERSIDE OF GYPSUM BOARD TO ABOVE HIGHEST ADJACENT CEILING
EXTEND ENTIRE BECK, EXTEND PARTITION TO 6" PARTITION TO FINISHED UNDERSIDE OF GYPSUM BOARD TO ABOVE HIGHEST ADJACENT CEILING
EXTEND ENTIRE BECK, EXTEND PARTITION TO 6" PARTITION TO FINISHED UNDERSIDE OF GYPSUM BOARD TO ABOVE HIGHEST ADJACENT CEILING
INDICATES BECK, EXTEND PARTITION TO 6" PARTITION TO FINISHED UNDERSIDE OF GYPSUM BOARD TO ABOVE HIGHEST ADJACENT CEILING
HEIGHT AS INDICATED IN SUBSCRIPT

Revisions:	Date:

CONSULTANT

IMEG

ARCHITECT/ENGINEER OF RECORD

ANDERSON

13605 1st Ave. N. #100 Plymouth, MN 55441
P 763.412.4000 | F 763.412.4090 | ae-mm.com
Anderson Engineering of Minnesota, LLC | Proj # 16584

STAMP

DATE: 08/04/2022
License # 9335

Office of Construction and Facilities Management

U.S. Department of Veterans Affairs

Drawing Title

INTERIOR PARTITION TYPES AND DETAILS

Approved:

Phase

BID DOCUMENTS

FULLY SPRINKLERED

Project Title

CONSTRUCT NEW SPS

Location

Sioux Falls, SD.

Issue Date

08/04/2022

Checked

Checker

Drawn

Author

Project Number

438-460









Building Number

5










Drawing Number

AE001

A

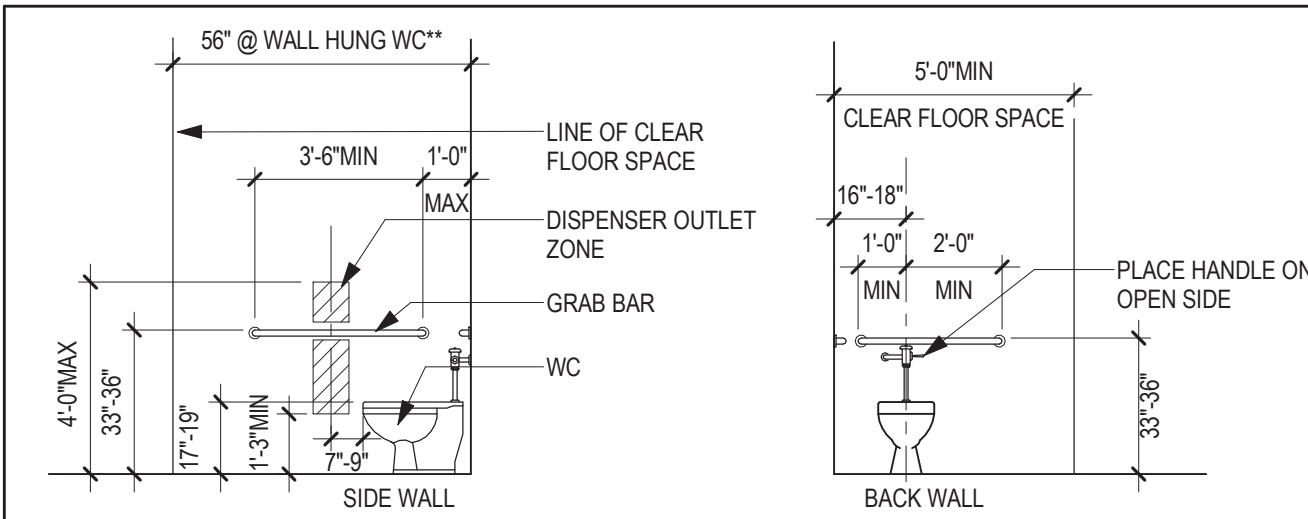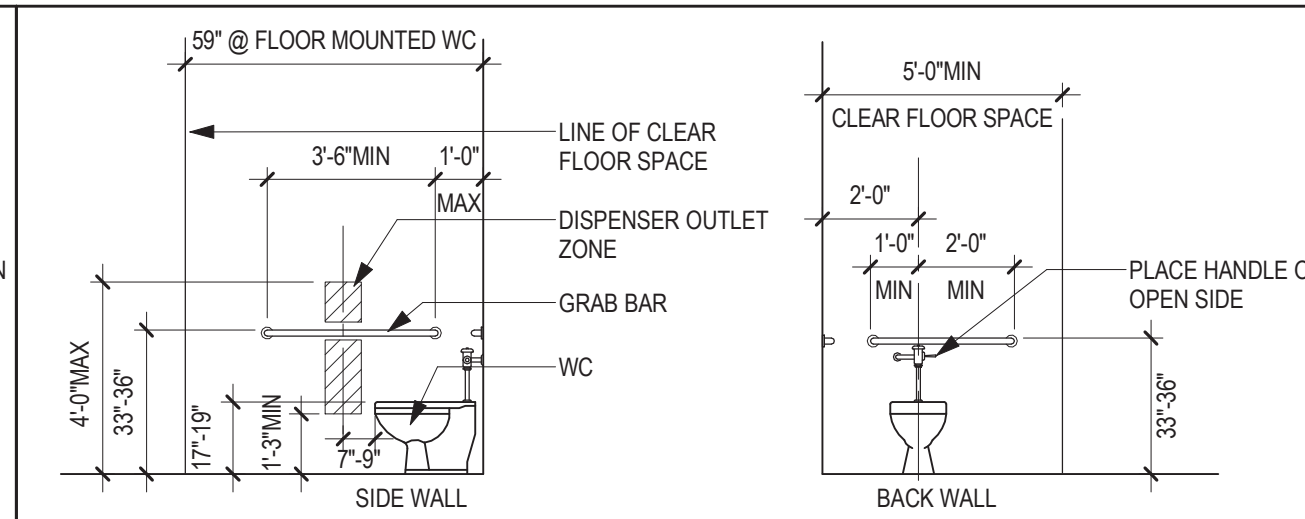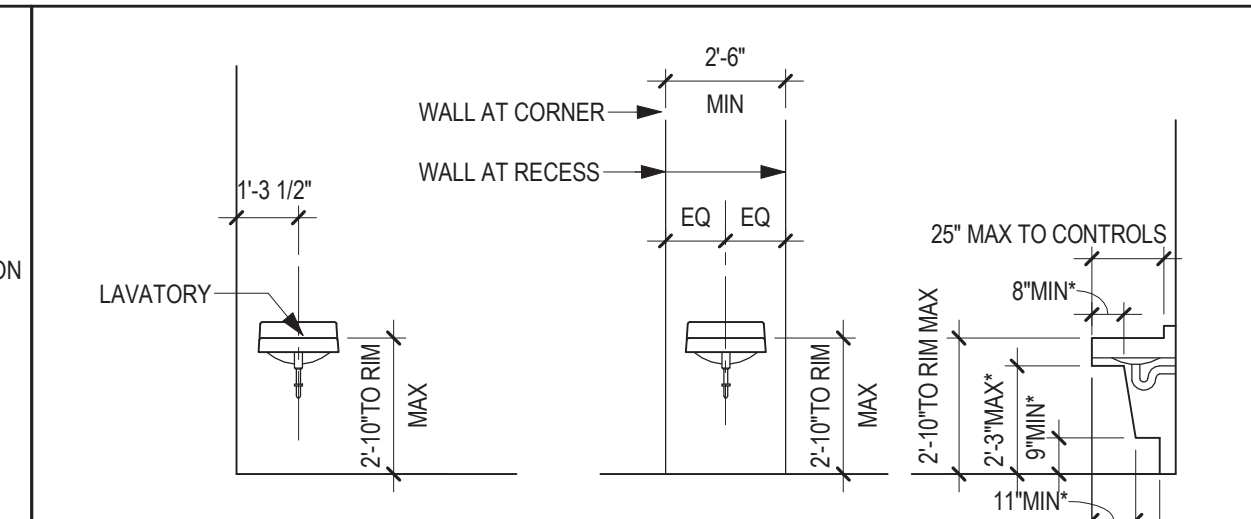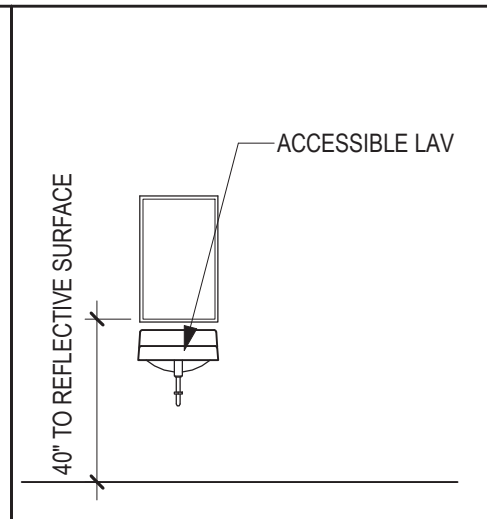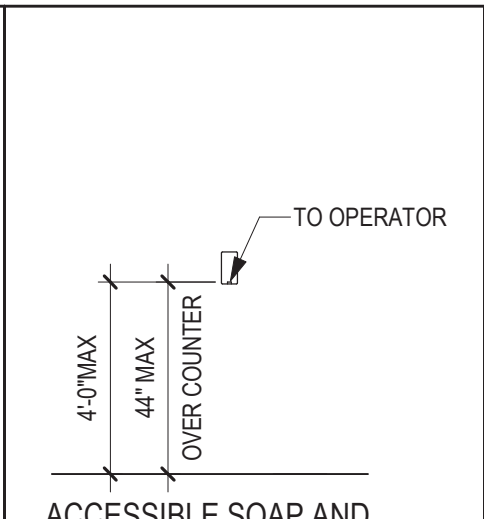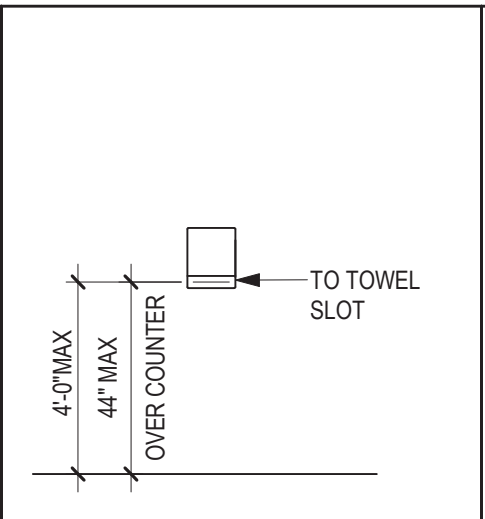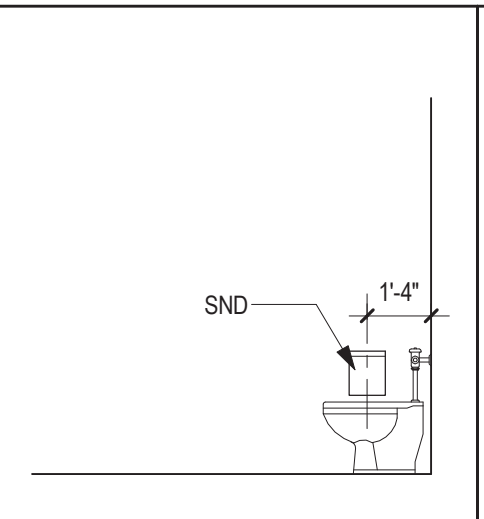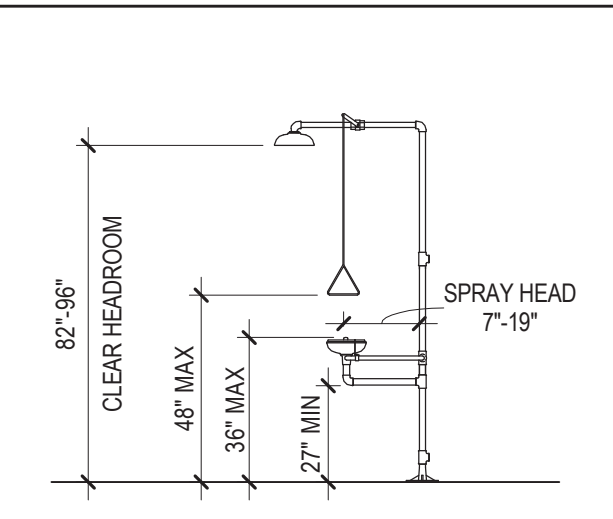 ACCESSIBLE TOILET/WATER CLOSETS 1. SANITARY NAPKIN DISPOSAL. PROVIDE AT UNISEX, & WOMEN'S PATIENT BATHROOMS ONLY. 2. DISPENSERS MAY NOT BE LOCATED BEHIND GRAB BARS. * AT TOILET COMPARTMENTS ** AT TOILET COMPARTMENTS AND SINGLE OCCUPANCY	 ACCESSIBLE BARIATRIC TOILET/WATER CLOSETS 1. SANITARY NAPKIN DISPOSAL. PROVIDE AT UNISEX, & WOMEN'S PATIENT BATHROOMS ONLY. 2. DISPENSERS MAY NOT BE LOCATED BEHIND GRAB BARS.	 ACCESSIBLE LAVATORY BASIN/BATHROOMS 1. SEE PLAN FOR SPECIFIC LOCATION CONDITION 2. SDRSD & PTC - VC 3. * KNEE CLEARANCE 4. SEE ACCESSIBLE MIRROR AT LAV FOR ADDITIONAL INFORMATION	 ACCESSIBLE MIRROR 1. SEE INTERIOR ELEVATIONS FOR MIRROR SIZE	 ACCESSIBLE SOAP AND HAND SANITIZER DISPENSER	 ACCESSIBLE PTD	 SANITARY NAPKIN DISPOSAL 1. SANITARY NAPKIN DISPOSAL. PROVIDE AT UNISEX, & WOMEN'S PATIENT BATHROOMS ONLY.	 EMERGENCY SHOWER/EYEWASH
--	--	---	---	--	--	---	--

B

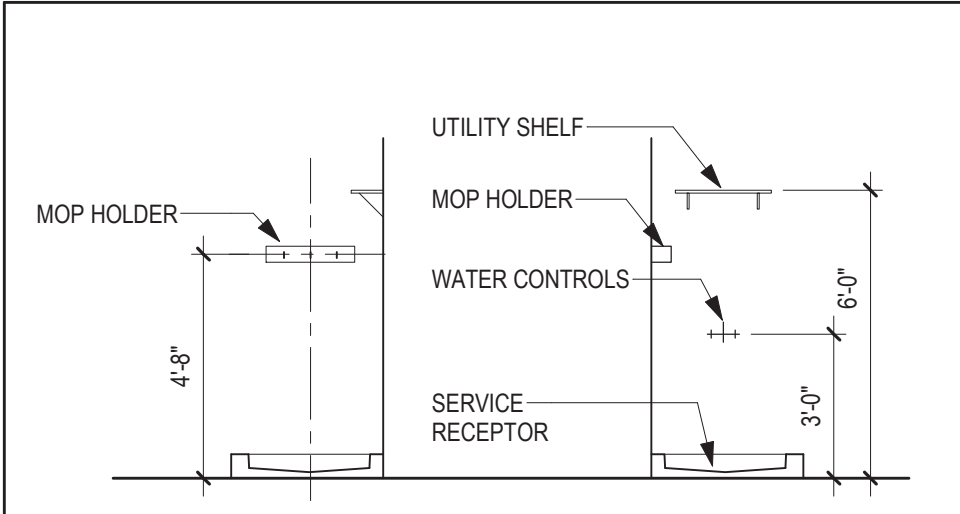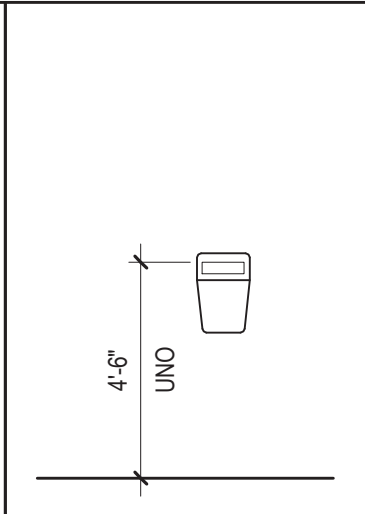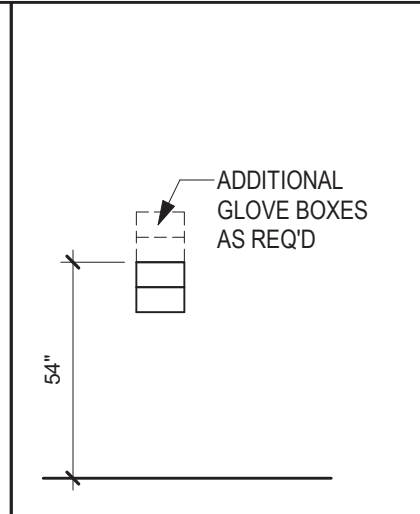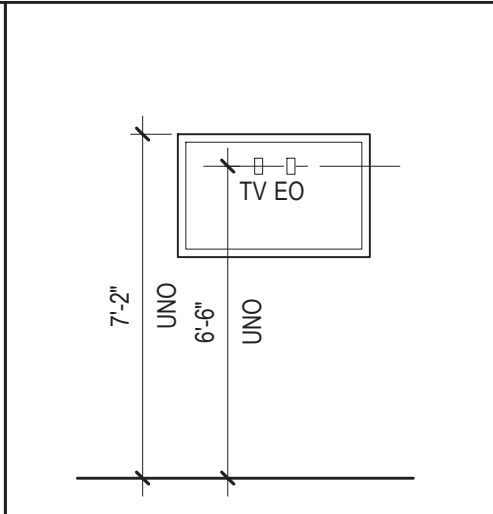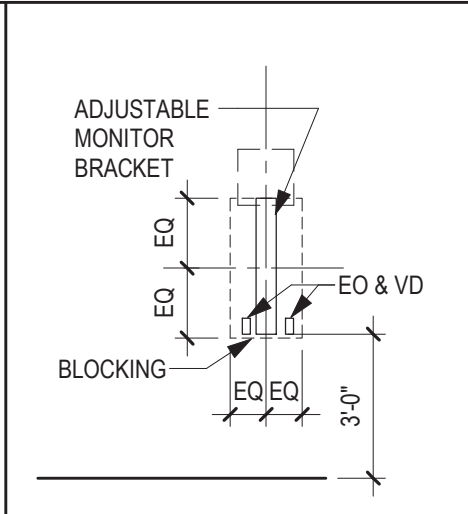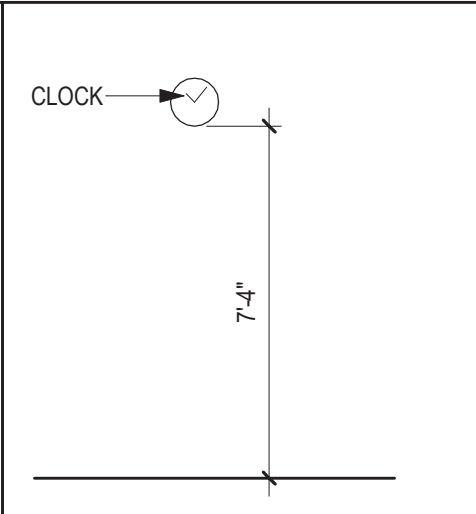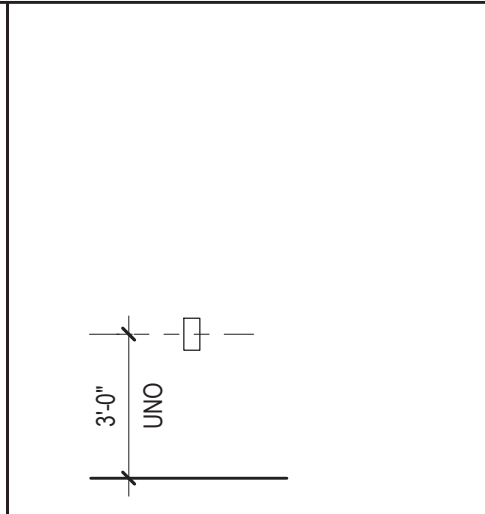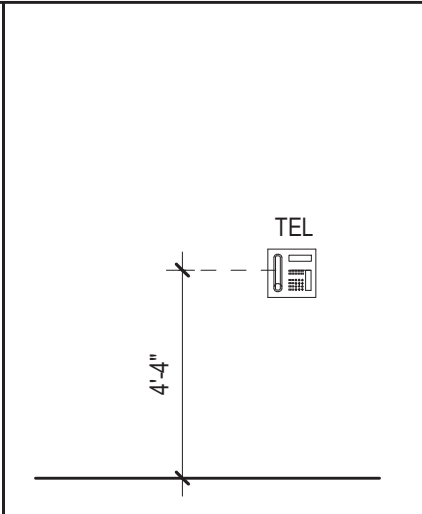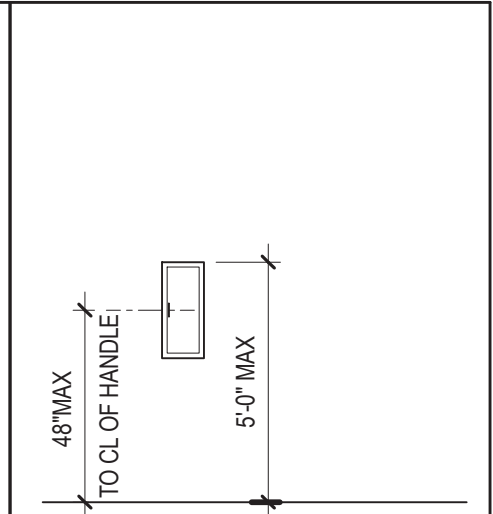 HOUSEKEEPING/EVS CLOSET 1. UTILITY SHELF 24" LONG UNO 2. WATER CONTROLS AND SERVICE RECEPTOR - SEE MECHANICAL	 SHARPS CONTAINER	 GLOVE BOX 2 GLOVE BOXES SHOWN. REFER TO ELEV FOR REQ'D QTY. ADDITIONAL BOXES MOUNTED ABOVE 4'-0" / 1200mm.	 FLAT TV SCREEN/ MONITORS PROVIDE PARTITION BLOCKING	 PC MOUNTING BRACKET ADJUSTABLE VERTICAL SLIDE MONITOR BRACKET	 WALL CLOCK -SEE ELECTRICAL DRAWINGS	 CARD READER - SEE ELECTRICAL AND COMMUNICATION DRAWINGS	 WALL PHONE	 FIRE EXTINGUISHER CABINET (FEC)
--	--	---	---	--	--	--	--	---

TYPICAL MOUNTING HEIGHTS

D

F

F

Revisions:	Date:

CONSULTANT




ARCHITECT/ENGINEER OF RECORD



13605 1st Ave. N. #100 Plymouth, MN 55441
P 763.412.4000 | F 763.412.4090 | ae-mn.com
Anderson Engineering of Minnesota, LLC | Proj # 16684

STAMP

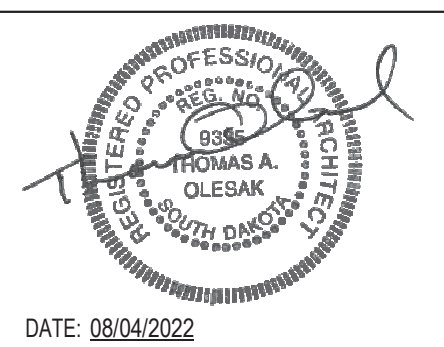

DATE: 08/04/2022
License # 9335

Office of Construction and Facilities Management



U.S. Department of Veterans Affairs

Drawing Title

MOUNTING HEIGHTS

Approved:

Phase

BID DOCUMENTS

FULLY SPRINKLERED

Project Title

CONSTRUCT NEW SPS

Location
Sioux Falls, SD.

Issue Date
08/04/2022

Checked
Checker

Drawn
Author

Project Number
438-460

Building Number
5

Drawing Number
AE640