


BUILDINGS 54 AND 69 - EHRM INFRASTRUCTURE UPGRADES

St. Cloud VA Health Care System
Main Campus, St. Cloud, Minnesota

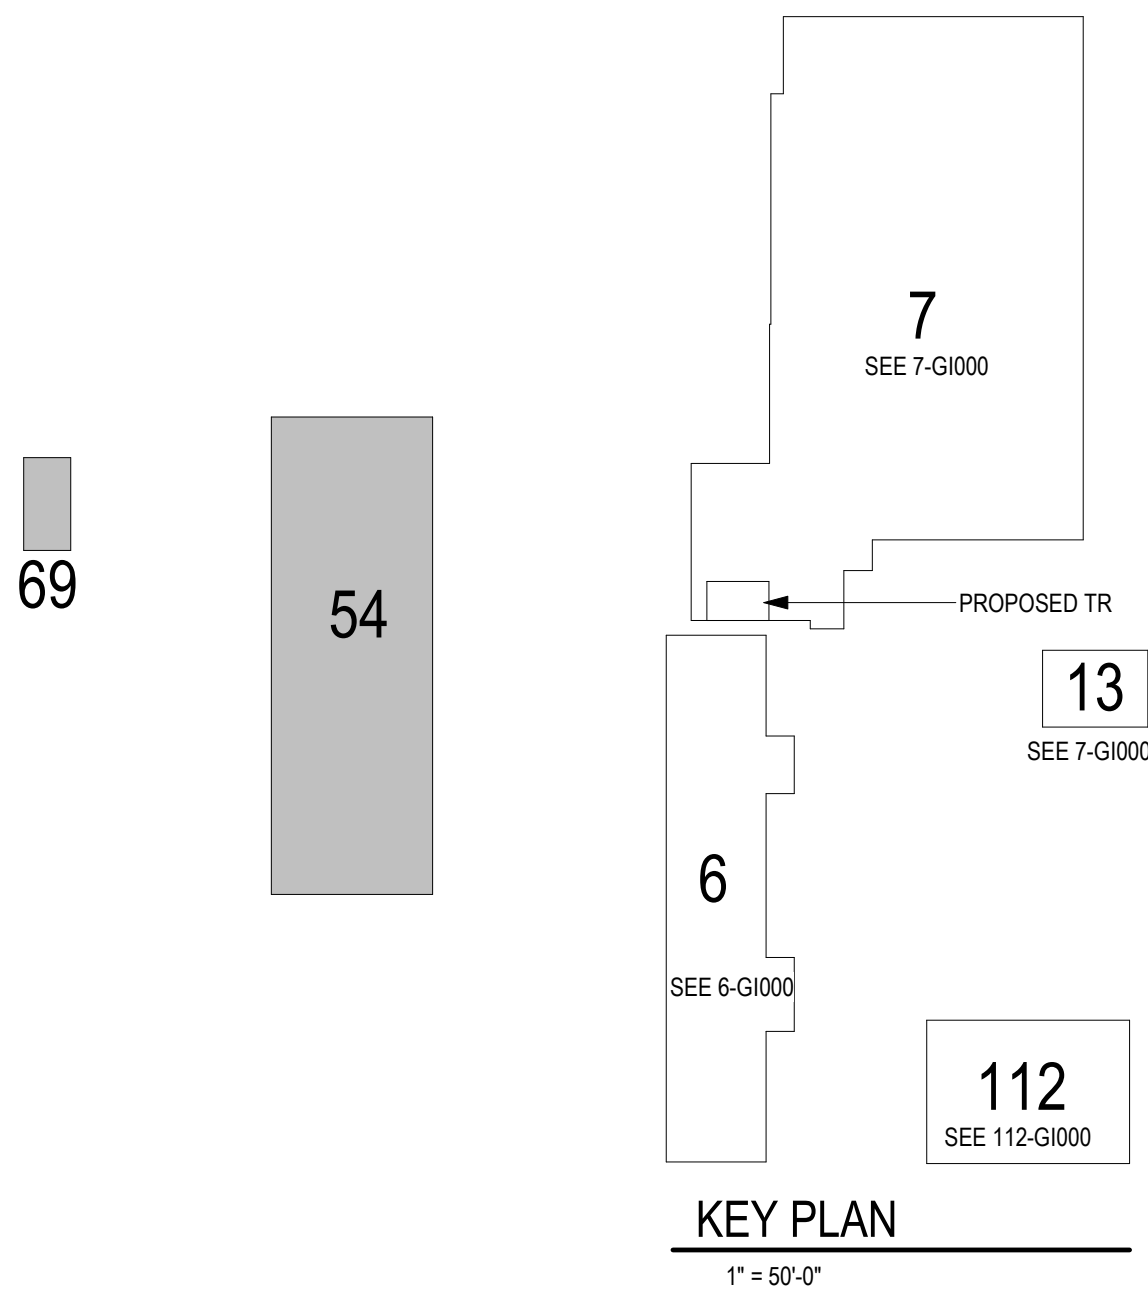

OWNER AND CONSULTANTS:

VA COR:
CONTACT: MIKE ENGMARK
ADDRESS: ST CLOUD VA MEDICAL CENTER
4801 VETERANS DRIVE
ST. CLOUD, MN 56303
PHONE: 320-252-1670
PROGRAM MANAGER:
CONTACT: JONATHAN WEST
ADDRESS: ST CLOUD VA MEDICAL CENTER
4801 VETERANS DRIVE
ST. CLOUD, MN 56303
PHONE: 504-250-2699
EMAIL: Jonathan.West@vcaint.com

CIVIL ENGINEER:
NAME: ANDERSON ENGINEERING OF MN, LLC
ADDRESS: 13605 1ST AVE NORTH, SUITE 100
PLYMOUTH, MN 55441

CONTACT: IAN WEBER
PHONE: 763-412-4000

ARCHITECT:
NAME: ANDERSON ENGINEERING OF MN, LLC
ADDRESS: 13605 1ST AVE NORTH, SUITE 100
PLYMOUTH, MN 55441

CONTACT: EDWARD MARKFORT
PHONE: 763-412-4000

STRUCTURAL ENGINEER:
NAME: ADVANCED STRUCTURAL TECHNOLOGIES
ADDRESS: 7301 OHMS LANE, SUITE 215
EDINA, MN 55439

CONTACT: ZACHARY CRAIG
PHONE: 952-854-9302


TELECOMMUNICATIONS ENGINEER:
NAME: SPECIALIZED ENGINEERING SOLUTIONS
ADDRESS: 10360 ELLISON CIRCLE
OMAHA, NE 68134

CONTACT: KRIS BURNHAM
PHONE: 402-991-5520

MECHANICAL/PLUMBING ENGINEER:
NAME: SPECIALIZED ENGINEERING SOLUTIONS
ADDRESS: 10360 ELLISON CIRCLE
OMAHA, NE 68134


CONTACT: KRIS BURNHAM
PHONE: 402-991-5520

VICINITY MAP:

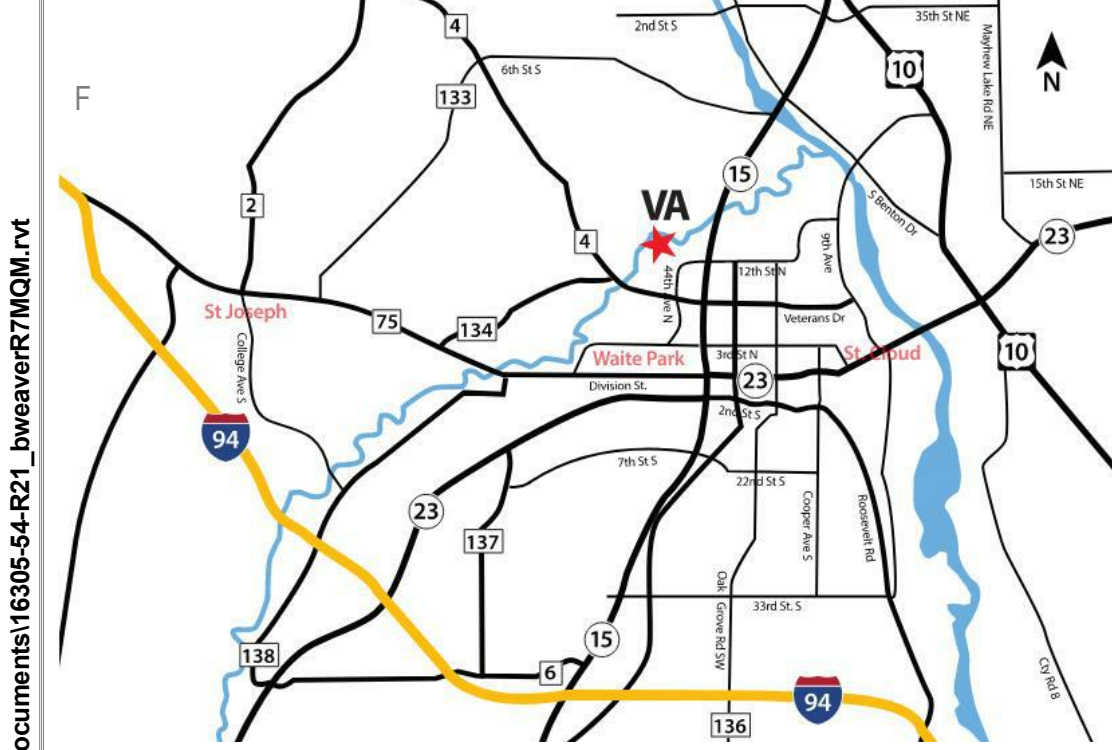

LEGEND

- EXISTING FIBER - INSIDE
- VFY EXIST
- EXISTING FIBER - OUTSIDE
- VFY EXIST
- FIBER ROUTE - INSIDE
- SEE TELECOM
- FIBER ROUTE - OUTSIDE
- SEE CIVIL
- BUILDING OUTLINE
- VFY EXIST
- CORRIDOR OUTLINE
- VFY EXIST

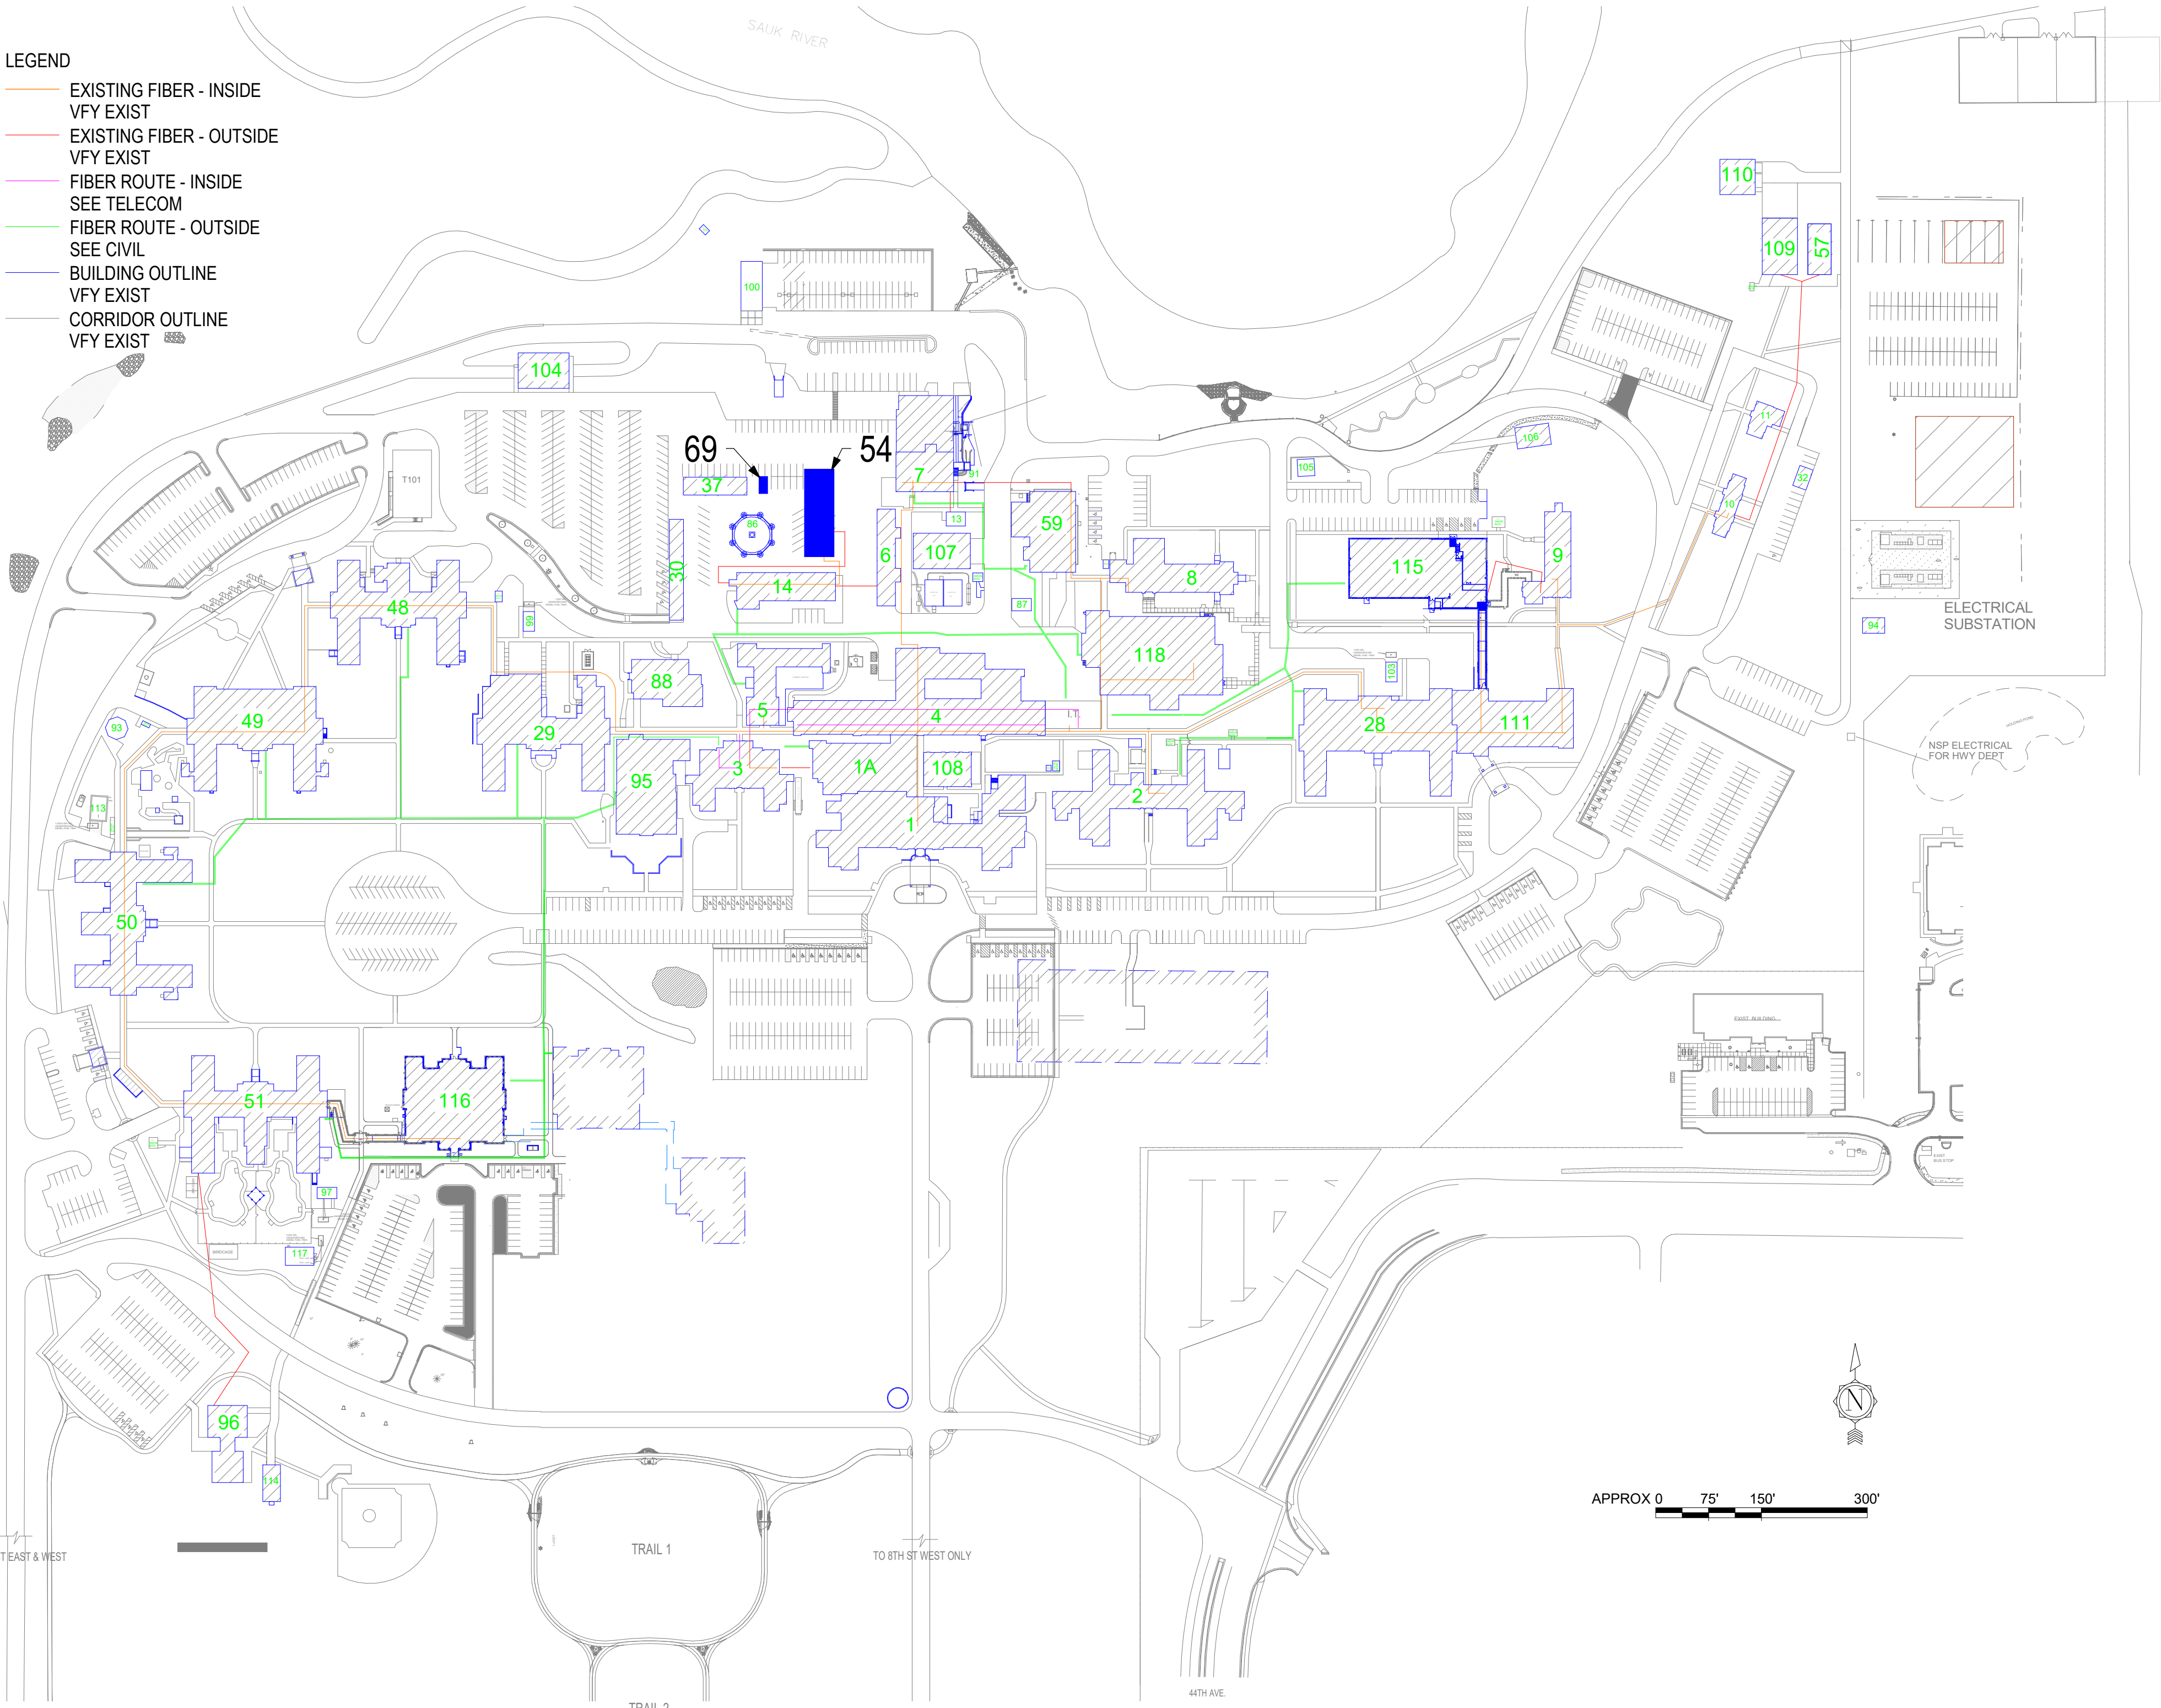

SHEET INDEX - BUILDINGS 54 & 69

SHEET NO.	SHEET TITLE
54-G1000	BUILDINGS 54 & 69 COVER SHEET & SHEET INDEX
54-HA 1A	REFERENCE - FIRST FLOOR ASBESTOS RE-SURVEY
54-AS110	FIRST FLOOR PLANS
SEE CAMPUS SHEETS FOR ADDITIONAL INFORMATION	

ROOM SCHEDULE

NO.	NAME	CABLING	PATCH PANEL	FIBER	POWER	BONDING	UPS	DEDICATED COOLING	TEMPERATURE	HUMIDITY	RACK SENSOR	SPACE	AREA	WIDTH (FT)	LENGTH (FT)	REMARKS
54	PLACEHOLDER BUILDING 54												5222 SF			SEE BUILDING 7 FOR TELECOM ROOM. SEE TELECOMMUNICATION DRAWINGS
69	PLACEHOLDER BUILDING 69												296 SF			SEE BUILDING 7 FOR TELECOM ROOM. SEE TELECOMMUNICATION DRAWINGS

HAZARDOUS MATERIAL SCHEDULE

BUILDING	ROOM NO.	ROOM NAME	QUESTIONABLE HAZARDOUS ELEMENT	POSSIBLE ABATEMENT ACTION
54	54	PLACEHOLDER BUILDING 54	ACM. SEE 54-HA-1A	NONE. ACM TO REMAIN UNDISTURBED.
69	69	PLACEHOLDER BUILDING 69	NONE	NONE

HAZARDOUS MATERIALS MAY BE ENCOUNTERED THROUGHOUT THE DISTRIBUTION ROUTING THROUGH CEILING PLenums AND UTILITY TUNNELS. INSTALLATION OF DISTRIBUTION SHALL NOT DISTURB QUESTIONABLE HAZARDOUS MATERIAL.

ICRA PHASE CONSTRUCTION ROOM SCHEDULE

BUILDING NO.	ROOM NO.	ROOM NAME	CAI BLDG NAME / FUNCTION	CONSTRUCTION PROJECT ACTIVITY	INFECTION CONTROL RISK GROUP	CONTROL PROCEDURE CLASS	SECTION	CONSTRUCTION ZONE / OCCUPIED CONSTR	DAY / NIGHT
54	54	PLACEHOLDER BUILDING 54	STATION GARAGE	CLASS A	GROUP 1	CLASS I	CENTER	OCCUPIED CONSTRUCTION	DAY
69	69	PLACEHOLDER BUILDING 69	WASTE STORAGE	CLASS A	GROUP 1	CLASS I	CENTER	OCCUPIED CONSTRUCTION	DAY

SEE GENERAL NOTES SHEET FOR CONSTRUCTION INFECTION CONTROL RISK ASSESSMENT (ICRA) DESCRIPTIONS. TYPE, GROUP AND CLASS SELECTED TO BEST OF DESIGN TEAM'S KNOWLEDGE. FINAL DETERMINATION BY THE VA WILL BE MADE AT A LATER DATE.

LEAK PREVENTION / DIVERTER SCHEDULE

VA Building Number	ROOM NO.	ROOM NAME	OVERHEAD LEAK DIVERTER AND DRAIN PIPING	LEAK PREVENTION BARRIER WATERPROOFING
54	54	PLACEHOLDER BUILDING 54		
69	69	PLACEHOLDER BUILDING 69		

SEE GENERAL NOTES SHEET FOR DETAIL. MWP = MEMBRANE WATERPROOFING. MASONRY = FLUID-APPLIED WATERPROOFING. INT = INTERIOR. EXT = EXTERIOR

C:\Users\lwaaver\Documents\16305-54-R21_lwaaver\TMCM.mxd

NO.	REVISION	DATE

CONSULTANT

AST **SPECIALIZED ENGINEERING SOLUTIONS**
10360 Ellison Circle
Omaha, NE 68134
Phone: 402.991.5520
www.specializedeng.com

ARCHITECT/ENGINEER OF RECORD

ANDERSON
13605 1st Ave. N. #100 Plymouth, MN 55441
P 763.412.4000 | F 763.412.4090 | ae-mn.com
Anderson Engineering of Minnesota, LLC | Proj # 16305

STAMP


I hereby certify that this plan, specification or report was prepared by me or under my direct supervision and that I am a duly Licensed Architect under the laws of the State of Minnesota.
Name: *Tom Oleasak*
Typed or Printed Name: Tom Oleasak
Date: 03/30/2022 License Number: MN# 18157

APPROVED: _____ DATE: _____	APPROVED: PROJECT COOR. _____ DATE: _____	APPROVED: PATIENT SAFETY _____ DATE: _____	APPROVED: O&M MANAGER _____ DATE: _____	APPROVED: DIRECTOR F&B _____ DATE: _____
APPROVED: _____ DATE: _____	APPROVED: SERVICE LINE DIRECTOR _____ DATE: _____	APPROVED: SAFETY MANAGER _____ DATE: _____	APPROVED: MO MANAGER _____ DATE: _____	APPROVED: ASSOCIATE DIRECTOR _____ DATE: _____
APPROVED: _____ DATE: _____	APPROVED: O&M COORDINATOR _____ DATE: _____	APPROVED: CHIEF OF POLICE _____ DATE: _____	APPROVED: PROJECTS SECTION MANAGER _____ DATE: _____	APPROVED: NURSE EXECUTIVE _____ DATE: _____
APPROVED: _____ DATE: _____	APPROVED: INFECTION CONTROL NURSE _____ DATE: _____	APPROVED: O&M MANAGER _____ DATE: _____	APPROVED: ASSISTANT CHIEF ENGINEER _____ DATE: _____	APPROVED: CHIEF OF STAFF _____ DATE: _____

 

 

DRAWING TITLE
BUILDINGS 54 & 69 COVER SHEET & SHEET INDEX

PROJECT FILE EHRM INFRASTRUCTURE UPGRADES	DATE 03/30/2022
PLOT SCALE 656-21-235	DRAWING NO. 54-G1000
BUILDING NO. 54 & 69	CHECKED BY EM
LOCATION VA MEDICAL CENTER ST. CLOUD, MN 56303	FULLY SPRINKLERED
DWG. OF	COVER OF

VA **U.S. Department of Veterans Affairs**
Veterans Health Administration
St. Cloud VA Health Care System

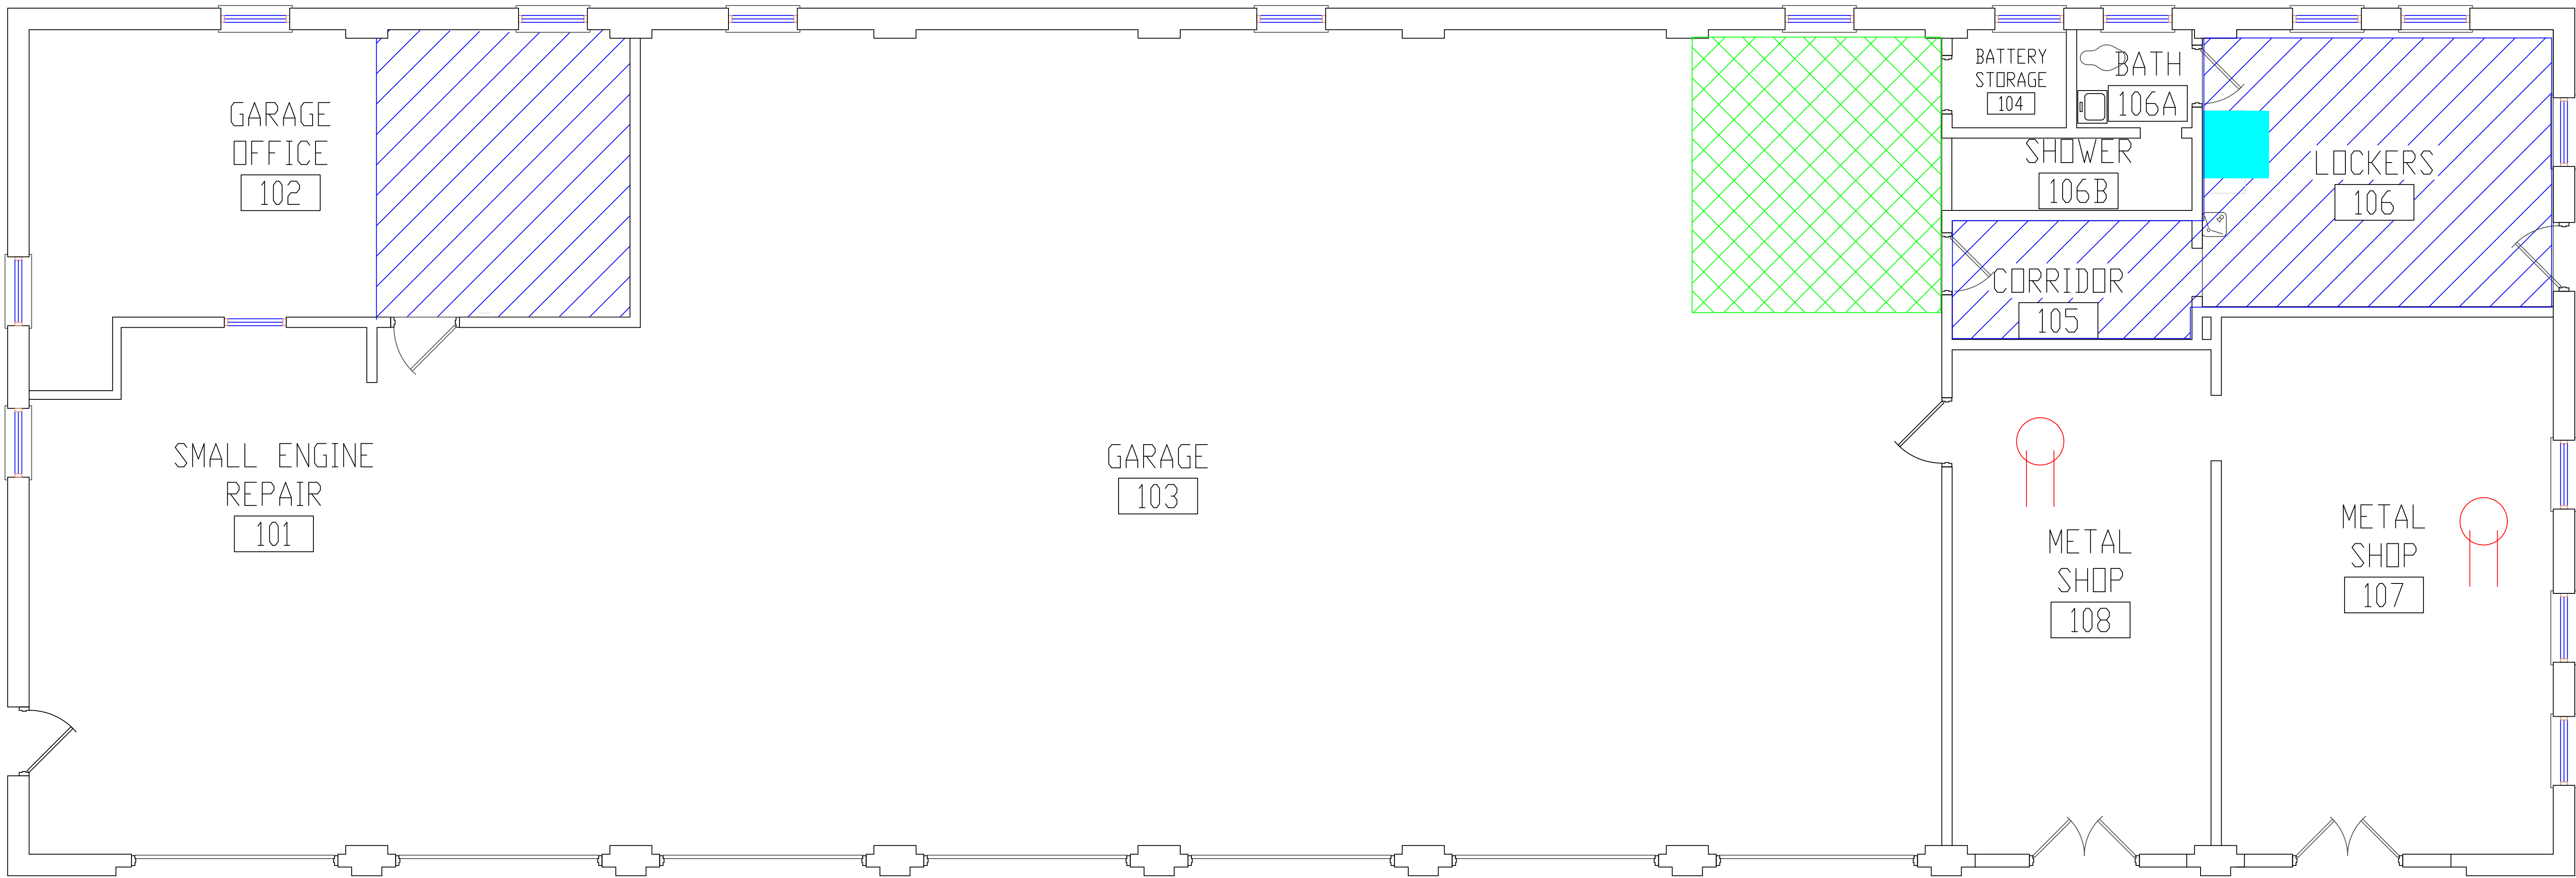


LEGEND

-  -ASBESTOS-CONTAINING PIPE FITTING INSULATION
-  -ASBESTOS-CONTAINING SINK UNDERCOATING
-  -ASBESTOS-CONTAINING 12"X12" FLOOR TILE AND MASTIC
-  -ASBESTOS-CONTAINING MASTIC BENEATH NON-ACM 12"X12" FLOOR TILE

BUILDING #54 - FIRST FLOOR PLAN

<div>Revisions</div> <div>Dates</div>		<div>ENVIRONMENTAL CONSULTANT: CASTLE HILL ASSOCIATES, LLC. 218-A MECHANIC STREET, WATERVILLE, OHIO 43566 Tel: (567) 952-0212</div>	<div> CASTLE HILL ASSOCIATES</div>	<div>Professional Seal: </div>	<div>North: </div>	<div>Drawing Title ARCHITECTURAL PLAN BUILDING 54 Scale: 1/4" = 1'-0"</div> <div>Approved : Division Chief</div> <div>Approved : Service Director</div>	<div>Project Title FACILITY ASBESTOS RE-SURVEY VETERANS ADMINISTRATION MEDICAL CENTER ST. CLOUD, MINNESOTA</div> <div>Building Number 054</div> <div>Location ST. CLOUD, MINNESOTA</div>	<div>Checked BLB</div> <div>Drawn AFS</div>	<div>Date NOVEMBER 2019</div> <div>Project No. 36C26319P1003</div> <div>Drawing No. 1A</div> <div>Sheet 60 of 71</div>	<div> Office of Facilities</div> <div> Department of Veterans Affairs</div>
---------------------------------------	--	--	--	---	---	--	---	---	---	--

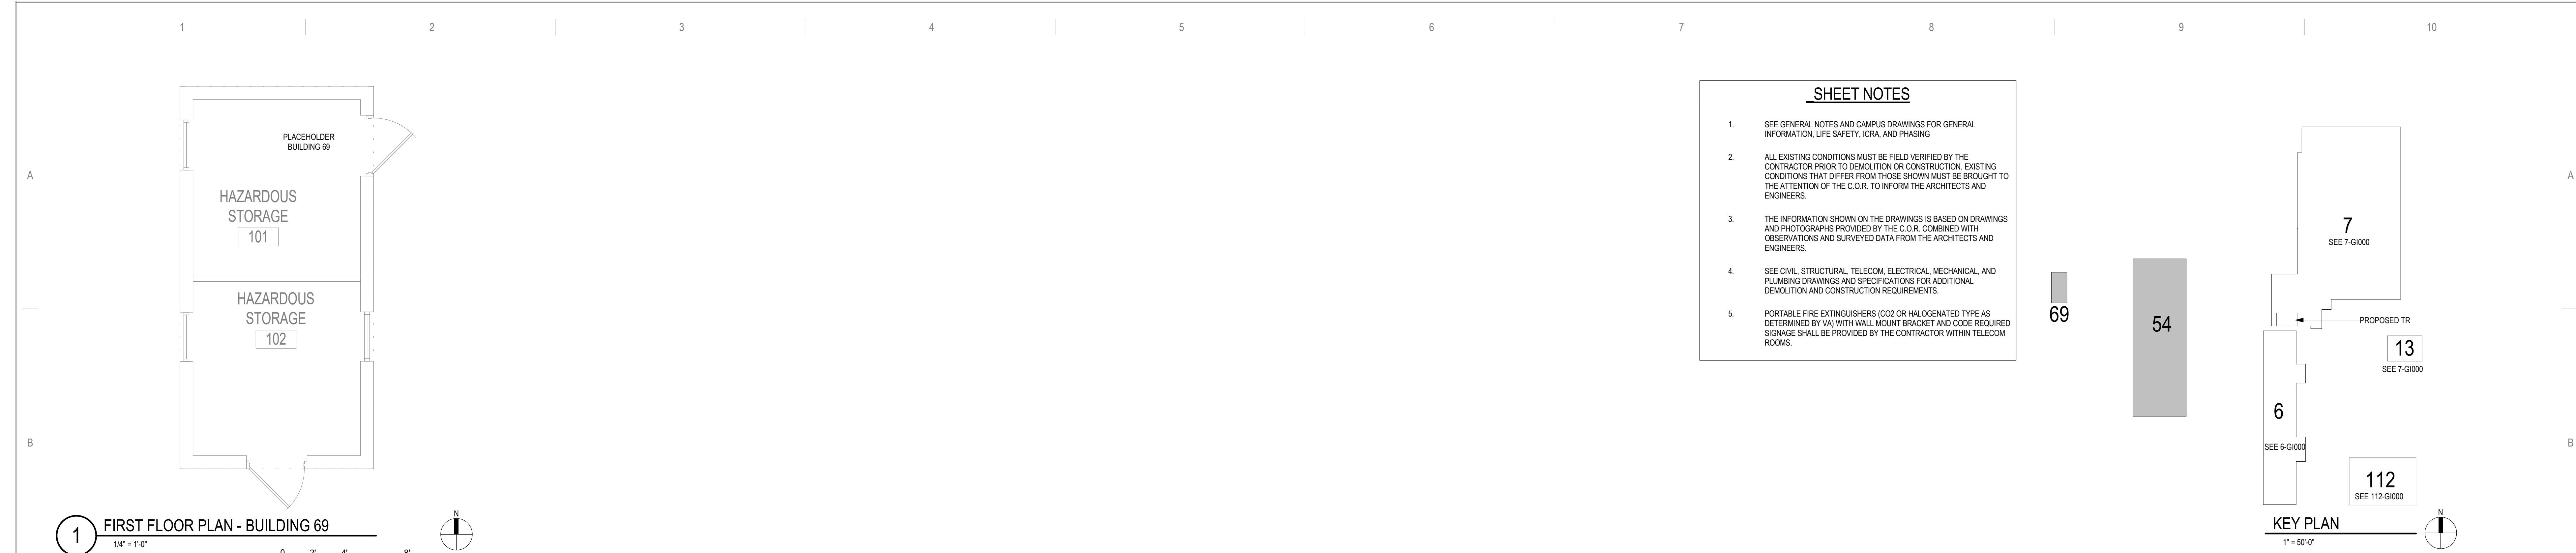

- SHEET NOTES**
- SEE GENERAL NOTES AND CAMPUS DRAWINGS FOR GENERAL INFORMATION, LIFE SAFETY, ICRA, AND PHASING
 - ALL EXISTING CONDITIONS MUST BE FIELD VERIFIED BY THE CONTRACTOR PRIOR TO DEMOLITION OR CONSTRUCTION. EXISTING CONDITIONS THAT DIFFER FROM THOSE SHOWN MUST BE BROUGHT TO THE ATTENTION OF THE C.O.R. TO INFORM THE ARCHITECTS AND ENGINEERS.
 - THE INFORMATION SHOWN ON THE DRAWINGS IS BASED ON DRAWINGS AND PHOTOGRAPHS PROVIDED BY THE C.O.R. COMBINED WITH OBSERVATIONS AND SURVEYED DATA FROM THE ARCHITECTS AND ENGINEERS.
 - SEE CIVIL, STRUCTURAL, TELECOM, ELECTRICAL, MECHANICAL, AND PLUMBING DRAWINGS AND SPECIFICATIONS FOR ADDITIONAL DEMOLITION AND CONSTRUCTION REQUIREMENTS.
 - PORTABLE FIRE EXTINGUISHERS (CO2 OR HALOGENATED TYPE AS DETERMINED BY VA) WITH WALL MOUNT BRACKET AND CODE REQUIRED SIGNAGE SHALL BE PROVIDED BY THE CONTRACTOR WITHIN TELECOM ROOMS.

C:\Users\lweaver\Documents\16305-54-F21_lweaver\RTMCM.mxd 3/29/2022 8:08:16 AM

<table><tr><td>No.</td><td>REVISION</td><td>DATE</td></tr><tr><td> </td><td> </td><td> </td></tr><tr><td> </td><td> </td><td> </td></tr><tr><td> </td><td> </td><td> </td></tr><tr><td> </td><td> </td><td> </td></tr><tr><td> </td><td> </td><td> </td></tr><tr><td> </td><td> </td><td> </td></tr><tr><td> </td><td> </td><td> </td></tr></table>		No.	REVISION	DATE																						<p>CONSULTANT</p> <p>AST SES SPECIALIZED ENGINEERING SOLUTIONS</p> <p>10360 Ellison Circle Omaha, NE 68134</p> <p>Phone: 402.991.5520 www.specializedeng.com</p>	<p>ARCHITECT/ENGINEER OF RECORD</p> <p>ANDERSON</p> <p>13605 1st Ave. N. #100 Plymouth, MN 55441 P 763.412.4000 F 763.412.4090 ae-mn.com Anderson Engineering of Minnesota, LLC Proj # 16305</p>	<p>STAMP</p> <p>I hereby certify that this plan, specification or report was prepared by me or under my direct supervision and that I am a duly Licensed Architect under the laws of the State of Minnesota.</p> <p>Name: <i>Tom Olesak</i></p> <p>Typed or Printed Name: Tom Olesak Date: 03/30/2022 License Number: MN# 18157</p>	<table><tr><td colspan="2">DRAWING TITLE</td></tr><tr><td colspan="2">FIRST FLOOR PLANS</td></tr></table> <table><tr><td>PROJECT TITLE</td><td>DATE</td></tr><tr><td>EHRM INFRASTRUCTURE UPGRADES</td><td>03/30/2022</td></tr><tr><td>PLOT SCALE</td><td></td></tr><tr><td>PROJECT NO.</td><td></td></tr><tr><td>656-21-235</td><td></td></tr><tr><td>DRAWING NO.</td><td></td></tr><tr><td>54-AS110</td><td></td></tr><tr><td>LOCATION</td><td></td></tr><tr><td>VA MEDICAL CENTER ST. CLOUD, MN 56303</td><td></td></tr><tr><td>FULLY SPRINKLERED</td><td>DWG. OF</td></tr></table>	DRAWING TITLE		FIRST FLOOR PLANS		PROJECT TITLE	DATE	EHRM INFRASTRUCTURE UPGRADES	03/30/2022	PLOT SCALE		PROJECT NO.		656-21-235		DRAWING NO.		54-AS110		LOCATION		VA MEDICAL CENTER ST. CLOUD, MN 56303		FULLY SPRINKLERED	DWG. OF	<p>VA</p> <p>U.S. Department of Veterans Affairs</p> <p>Veterans Health Administration St. Cloud VA Health Care System</p>
No.	REVISION	DATE																																																				
DRAWING TITLE																																																						
FIRST FLOOR PLANS																																																						
PROJECT TITLE	DATE																																																					
EHRM INFRASTRUCTURE UPGRADES	03/30/2022																																																					
PLOT SCALE																																																						
PROJECT NO.																																																						
656-21-235																																																						
DRAWING NO.																																																						
54-AS110																																																						
LOCATION																																																						
VA MEDICAL CENTER ST. CLOUD, MN 56303																																																						
FULLY SPRINKLERED	DWG. OF																																																					