

BUILDING 96 - EHRM INFRASTRUCTURE UPGRADES

St. Cloud VA Health Care System
Main Campus, St. Cloud, Minnesota

OWNER AND
CONSULTANTS:

VA COR:
CONTACT: MIKE ENGMARK
ADDRESS: ST CLOUD VA MEDICAL CENTER
4801 VETERANS DRIVE
ST. CLOUD, MN 56303
PHONE: 320-252-1670
PROGRAM MANAGER:
CONTACT: JONATHAN WEST
ADDRESS: ST CLOUD VA MEDICAL CENTER
4801 VETERANS DRIVE
ST. CLOUD, MN 56303
PHONE: 504-250-2699
EMAIL: Jonathan.West@vcaint.com

CIVIL ENGINEER:
NAME: ANDERSON ENGINEERING OF MN, LLC
ADDRESS: 13605 1ST AVE NORTH, SUITE 100
PLYMOUTH, MN 55441

CONTACT: IAN WEBER
PHONE: 763-412-4000

ARCHITECT:
NAME: ANDERSON ENGINEERING OF MN, LLC
ADDRESS: 13605 1ST AVE NORTH, SUITE 100
PLYMOUTH, MN 55441

CONTACT: EDWARD MARKFORT
PHONE: 763-412-4000

STRUCTURAL ENGINEER:
NAME: ADVANCED STRUCTURAL TECHNOLOGIES
ADDRESS: 7301 OHMS LANE, SUITE 215
EDINA, MN 55439

CONTACT: ZACHARY CRAIG
PHONE: 952-854-9302


TELECOMMUNICATIONS ENGINEER:
NAME: SPECIALIZED ENGINEERING SOLUTIONS
ADDRESS: 10360 ELLISON CIRCLE
OMAHA, NE 68134

CONTACT: KRIS BURNHAM
PHONE: 402-991-5520

MECHANICAL/ELECTRICAL ENGINEER:
NAME: SPECIALIZED ENGINEERING SOLUTIONS
ADDRESS: 10360 ELLISON CIRCLE
OMAHA, NE 68134


CONTACT: KRIS BURNHAM
PHONE: 402-991-5520

VICINITY MAP:

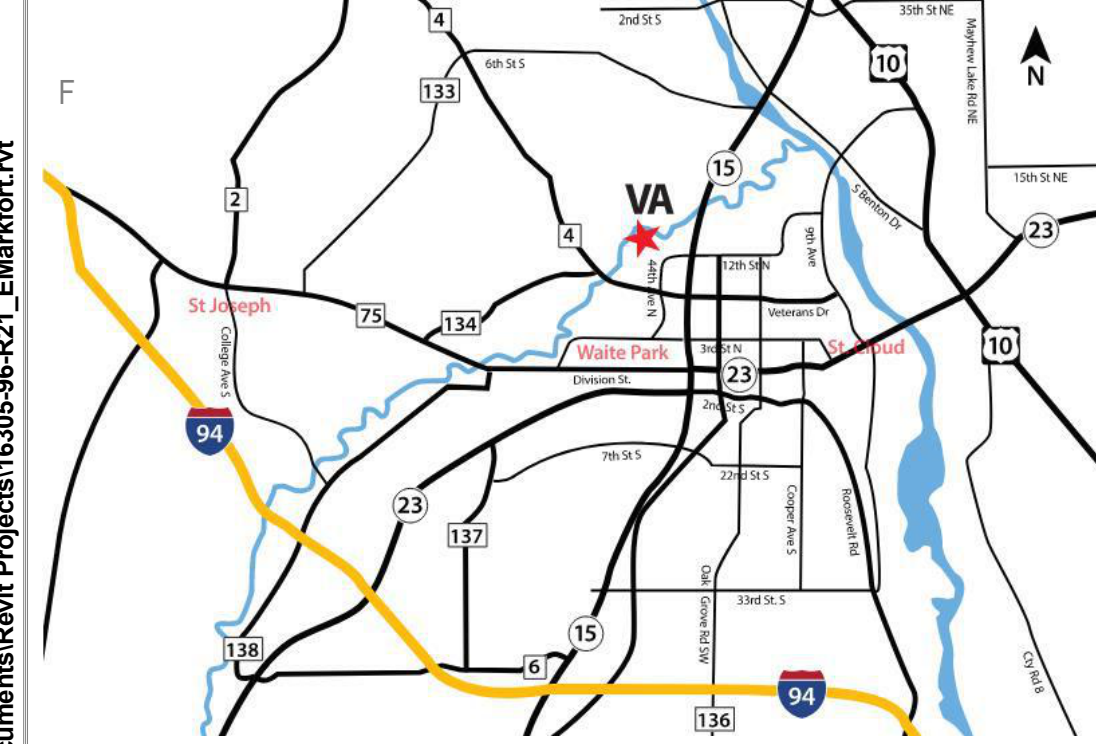

LEGEND

- EXISTING FIBER - INSIDE
- VFY EXIST
- EXISTING FIBER - OUTSIDE
- VFY EXIST
- FIBER ROUTE - INSIDE
- SEE TELECOM
- FIBER ROUTE - OUTSIDE
- SEE CIVIL
- BUILDING OUTLINE
- VFY EXIST
- CORRIDOR OUTLINE
- VFY EXIST

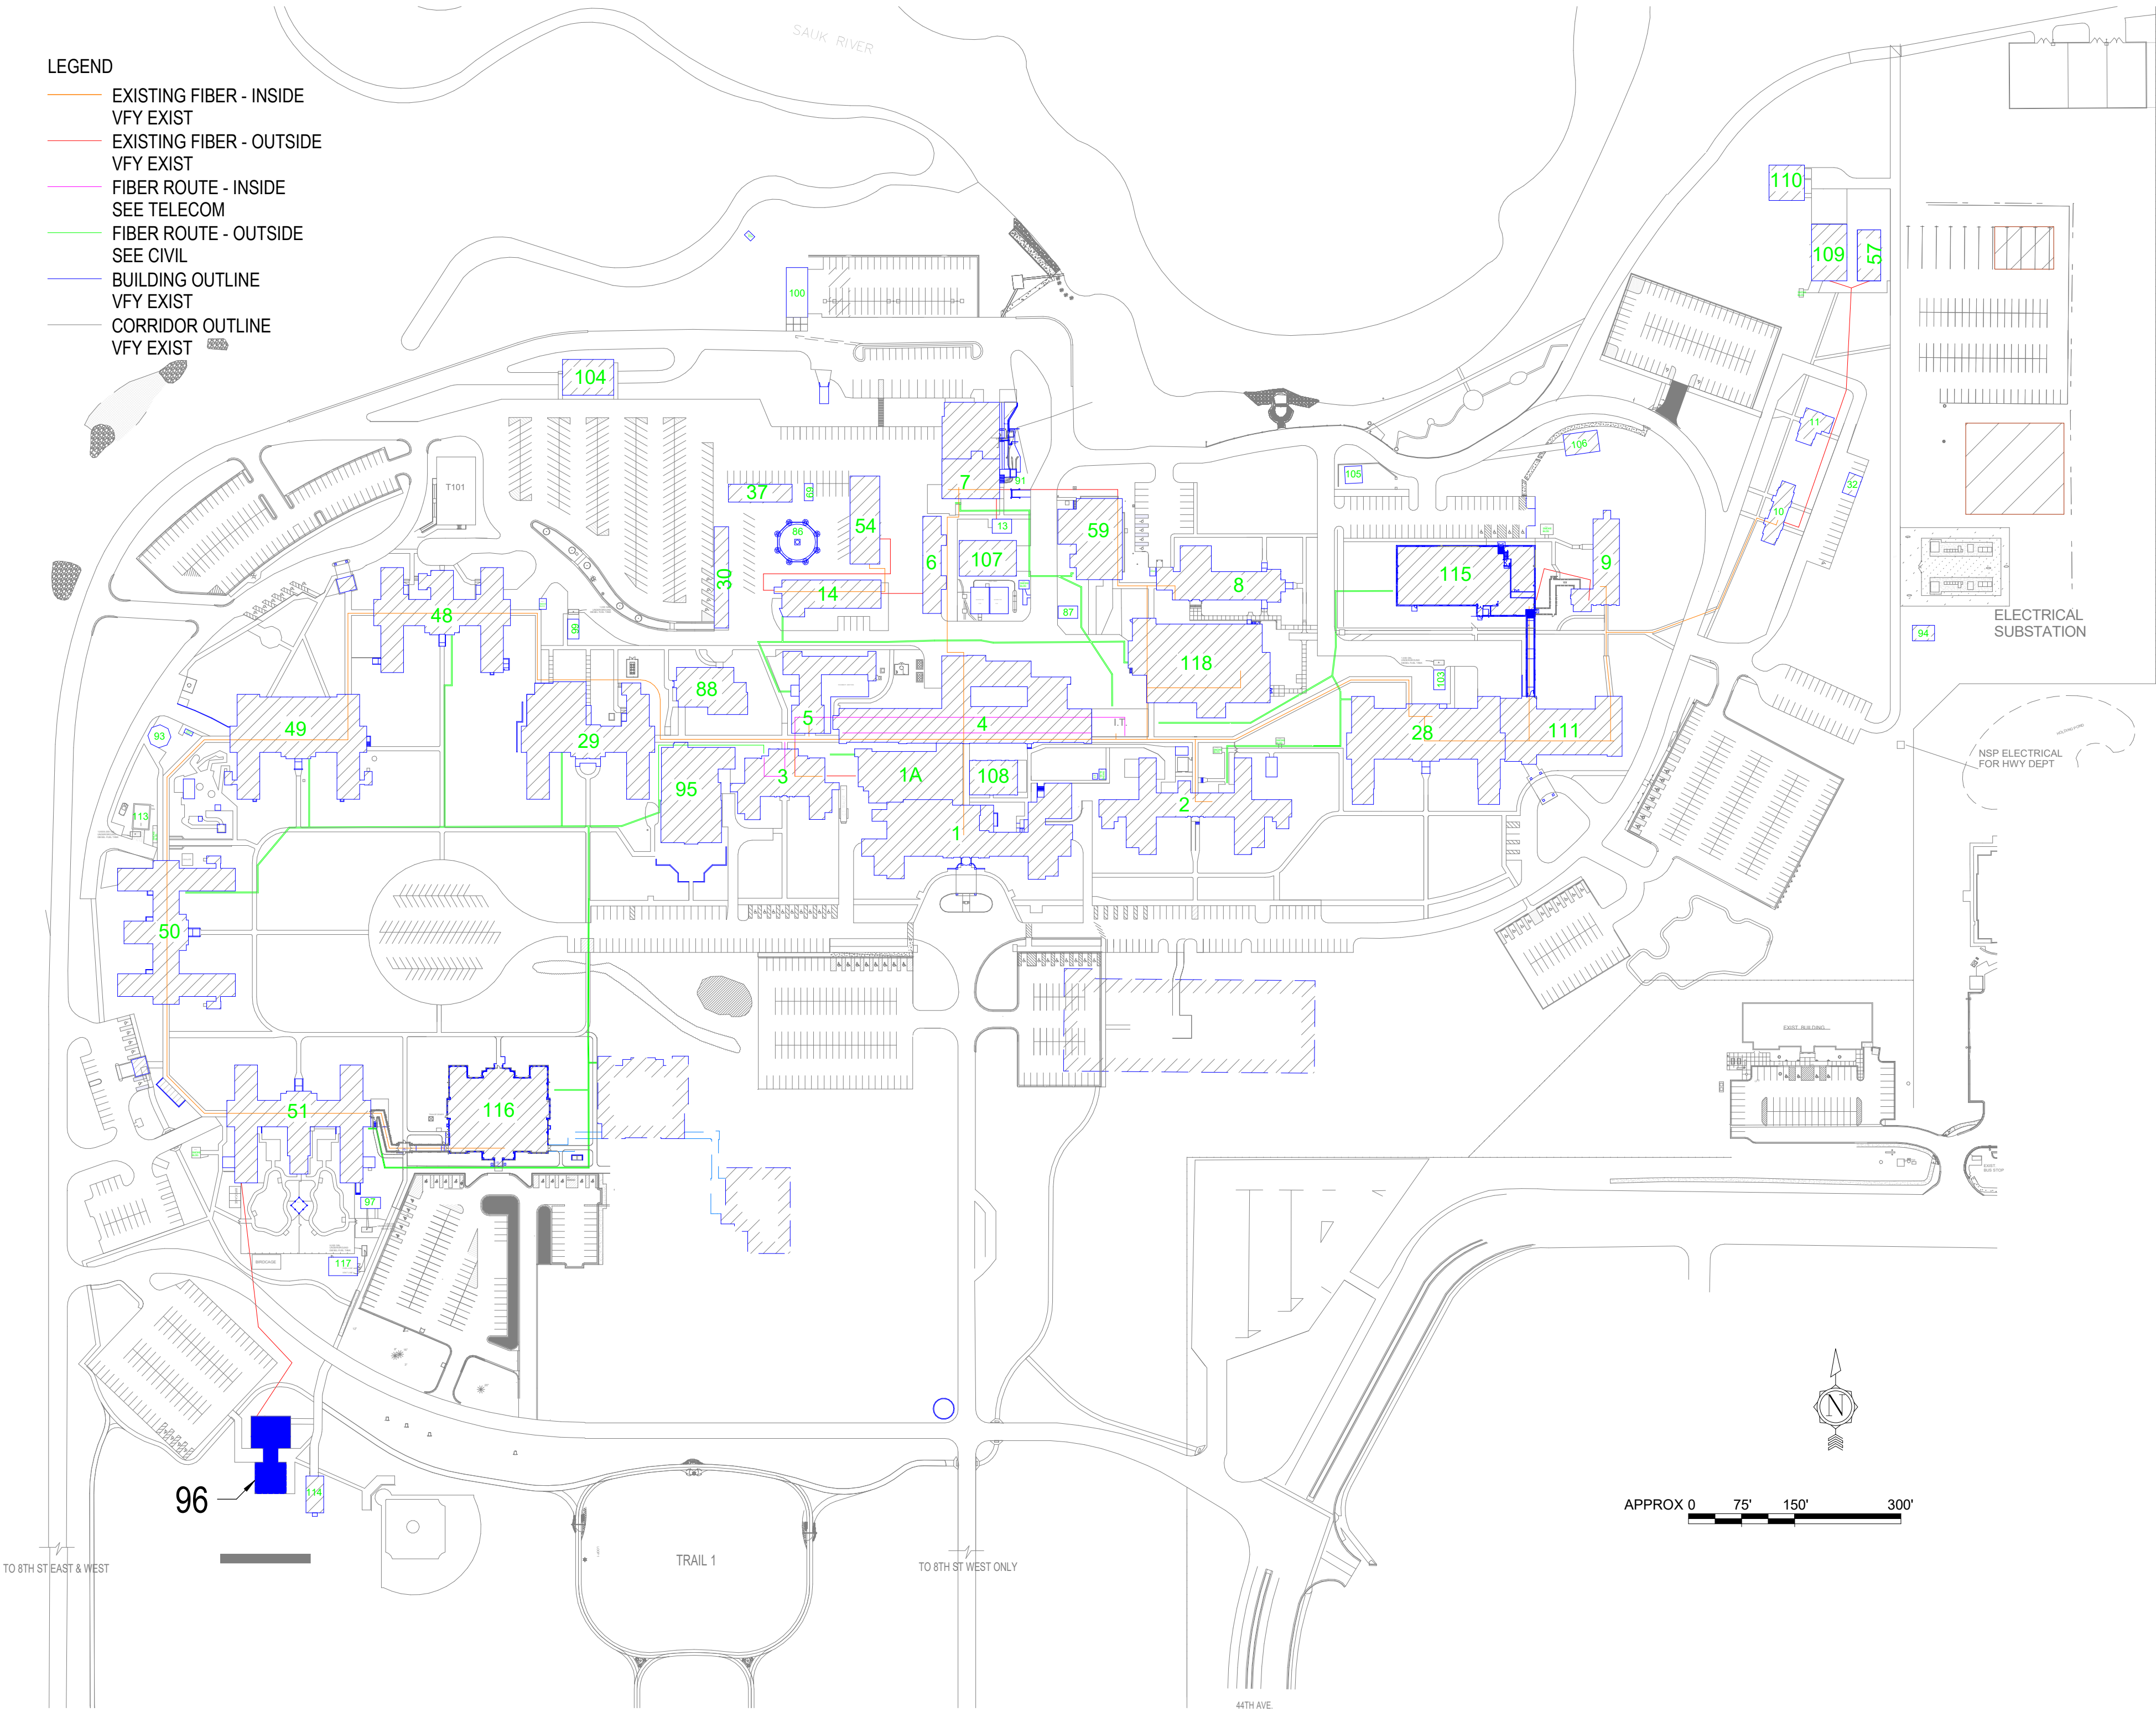

SHEET INDEX - BUILDING 96

SHEET NO.	SHEET TITLE
96-G1000	BUILDING 96 COVER SHEET & SHEET INDEX
96-G1111	FIRST FLOOR - INFECTION CONTROL & PHASING PLAN
96-HA-1A	REFERENCE - FIRST FLOOR ASBESTOS RE-SURVEY
96-AS110	FIRST FLOOR PLANS
96-TD110	FIRST FLOOR PLAN - TELECOM - DEMOLITION
96-TN110	FIRST FLOOR PLAN - TELECOMMUNICATIONS
96-TN210	FIRST FLOOR PLAN - TELECOM - CABLE DISTANCE
96-TN300	ENLARGED PLANS - TELECOMMUNICATIONS - DEMO
96-TN400	ENLARGED PLANS - TELECOMMUNICATIONS
96-E201	FIRST FLOOR PLAN - ELECTRICAL
SEE GENERAL SHEETS FOR ADDITIONAL INFORMATION	

ROOM SCHEDULE

NO.	NAME	CABELING	PATCH PANEL	FIBER	POWER	BONDING	UPS	DEDICATED COOLING	TEMPERATURE	HUMIDITY	RACK SENSOR	SPACE	AREA	WIDTH (FT)	LENGTH (FT)	HT TO CLG STRUCT	REMARKS
FIRST FLOOR	103	EXIST RM											34 SF				DECOMMISSION EXIST IT/DATA ROOM. SEE TELECOM DRAWINGS. RELOCATE TO 104B
104B	TELECOM ROOM	X	X	X	X	X	X	X	X	X			40 SF	7.2	5.6	14.00	UPDATE EXIST IT/DATA ROOM TO EHRM TELECOM ROOM STANDARDS. SEE TELECOM DRAWINGS

HAZARDOUS MATERIAL SCHEDULE

LEVEL	ROOM NO.	ROOM NAME	QUESTIONABLE HAZARDOUS ELEMENT	POSSIBLE ABATEMENT ACTION
FIRST FLOOR	103	EXIST RM	ACM AT WINDOWS. SEE 96-HA-1A	NONE. ACM TO REMAIN UNDISTURBED
FIRST FLOOR	104B	TELECOM ROOM	ACM AT WINDOWS. SEE 96-HA-1A	NONE. ACM TO REMAIN UNDISTURBED
HAZARDOUS MATERIALS MAY BE ENCOUNTERED THROUGHOUT THE DISTRIBUTION ROUTING THROUGH CEILING FLENUMS AND UTILITY TUNNELS. INSTALLATION OF DISTRIBUTION SHALL NOT DISTURB QUESTIONABLE HAZARDOUS MATERIAL.				

ICRA PHASE CONSTRUCTION ROOM SCHEDULE

LEVEL	ROOM NO.	ROOM NAME	CAI BLDG NAME / FUNCTION	CONSTRUCTION PROJECT ACTIVITY	INFECTION CONTROL RISK GROUP	CONTROL PROCEDURE CLASS	SECTION	CONSTRUCTION ZONE / OCCUPIED CONSTR	DAY / NIGHT
FIRST FLOOR	103	EXIST RM	RECREATION PAVILION	TYPE B	GROUP 1	CLASS II	WEST	OCCUPIED CONSTRUCTION	DAY
FIRST FLOOR	104B	TELECOM ROOM	RECREATION PAVILION	TYPE C	GROUP 1	CLASS II	WEST	OCCUPIED CONSTRUCTION	DAY
SEE GENERAL NOTES SHEET FOR CONSTRUCTION INFECTION CONTROL RISK ASSESSMENT (ICRA) DESCRIPTIONS. TYPE, GROUP AND CLASS SELECTED TO BEST OF DESIGN TEAM'S KNOWLEDGE. FINAL DETERMINATION BY THE VA WILL BE MADE AT A LATER DATE.									

LEAK PREVENTION / DIVERTER SCHEDULE

LEVEL	ROOM NO.	ROOM NAME	OVERHEAD LEAK DIVERTER AND DRAIN PIPING	LEAK PREVENTION BARRIER WATERPROOFING
FIRST FLOOR	103	EXIST RM		
FIRST FLOOR	104B	TELECOM ROOM		
SEE GENERAL NOTES SHEET FOR DETAIL. MWP = MEMBRANE WATERPROOFING. MASONRY = FLUID-APPLIED WATERPROOFING. INT = INTERIOR. EXT = EXTERIOR				

C:\Users\Public\Documents\Revit Projects\16305-96-R21_E\Markfort.rvt

NO.	REVISION	DATE

CONSULTANT



SPECIALIZED ENGINEERING SOLUTIONS

10360 Ellison Circle
Omaha, NE 68134

Phone: 402-991-5520
www.specializedeng.com

ARCHITECT/ENGINEER OF RECORD



13605 1st Ave. N. #100 Plymouth, MN 55441
P 763.412.4000 | F 763.412.4090 | ae-mn.com
Anderson Engineering of Minnesota, LLC | Proj # 16305

STAMP

I hereby certify that this plan, specification or report was prepared by me or under my direct supervision and that I am a duly Licensed Architect under the laws of the State of Minnesota.

Name: *Tom Olesak*
Typed or Printed Name: Tom Olesak
Date: 03/30/2022 License Number: MN# 18157


APPROVED: _____ DATE: _____	APPROVED: PROJECT COR _____ DATE: _____	APPROVED: PATIENT SAFETY _____ DATE: _____	APPROVED: DMS MANAGER _____ DATE: _____	APPROVED: DIRECTOR FMS _____ DATE: _____
APPROVED: _____ DATE: _____	APPROVED: SERVICE LINE DIRECTOR _____ DATE: _____	APPROVED: SAFETY MANAGER _____ DATE: _____	APPROVED: MO MANAGER _____ DATE: _____	APPROVED: ASSOCIATE DIRECTOR _____ DATE: _____
APPROVED: _____ DATE: _____	APPROVED: DMS COORDINATOR _____ DATE: _____	APPROVED: CHIEF OF POLICE _____ DATE: _____	APPROVED: PROJECTS SECTION MANAGER _____ DATE: _____	APPROVED: NURSE EXECUTIVE _____ DATE: _____
APPROVED: _____ DATE: _____	APPROVED: INFECTION CONTROL NURSE _____ DATE: _____	APPROVED: CHIEF OF STAFF _____ DATE: _____	APPROVED: ASSISTANT CHIEF ENGINEER _____ DATE: _____	APPROVED: CHIEF OF STAFF _____ DATE: _____
APPROVED: _____ DATE: _____	APPROVED: CHIEF OF STAFF _____ DATE: _____	APPROVED: CHIEF OF STAFF _____ DATE: _____	APPROVED: CHIEF OF STAFF _____ DATE: _____	APPROVED: CHIEF OF STAFF _____ DATE: _____

DRAWING TITLE
BUILDING 96 COVER SHEET & SHEET INDEX

PROJECT FILE EHRM INFRASTRUCTURE UPGRADES	DATE 03/30/2022
PLOT SCALE PROJECT NO. 656-21-235	DRAWING NO. 96-G1000
BUILDING NO. 96	CHECKED BY EM
LOCATION VA MEDICAL CENTER ST. CLOUD, MN 56303	COVER OF




U.S. Department of Veterans Affairs
Veterans Health Administration
St. Cloud VA Health Care System

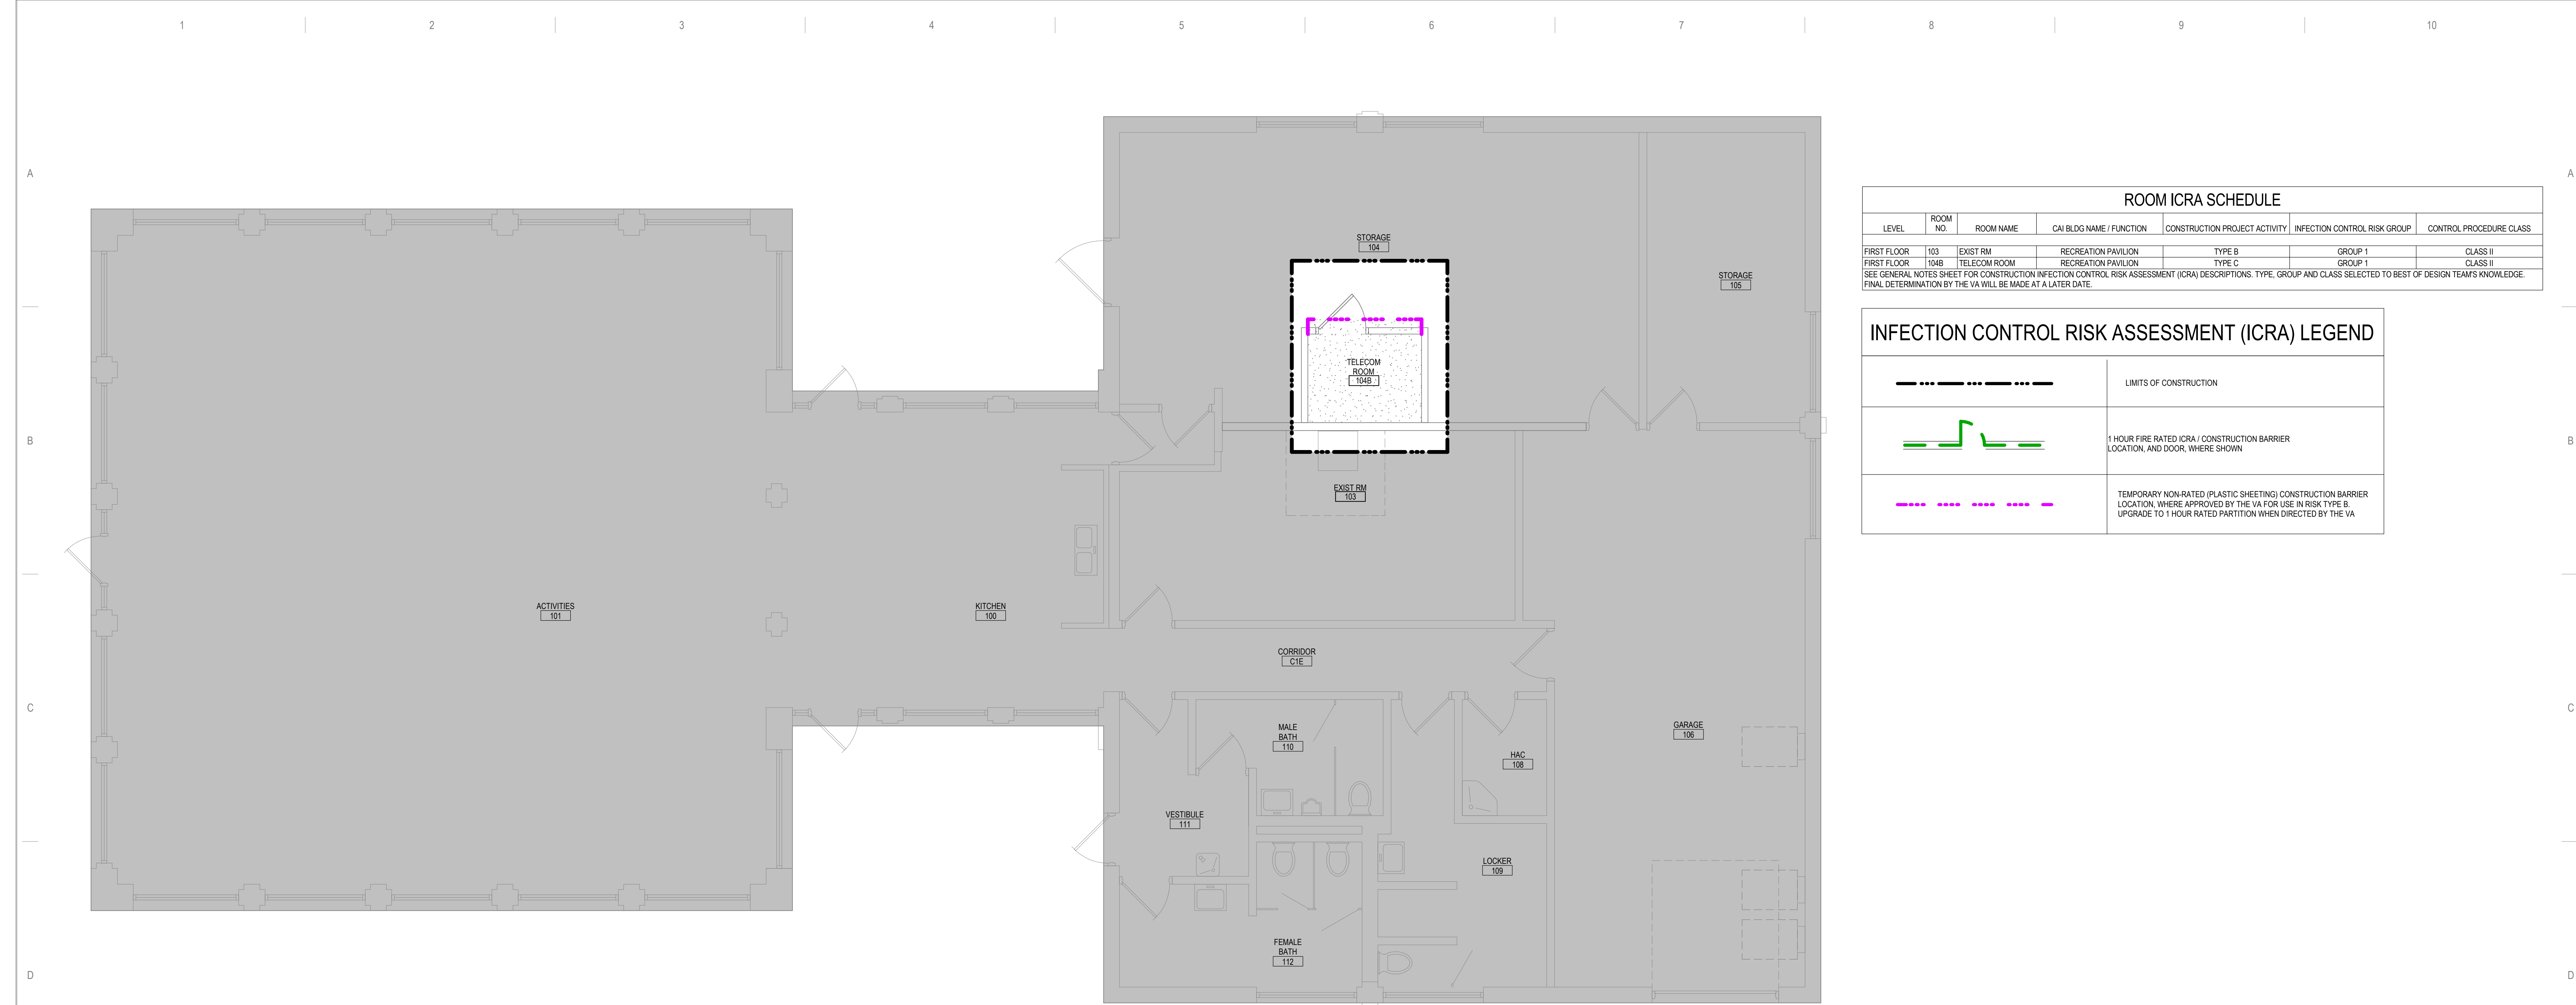

ROOM ICRA SCHEDULE						
LEVEL	ROOM NO.	ROOM NAME	CAI BLDG NAME / FUNCTION	CONSTRUCTION PROJECT ACTIVITY	INFECTION CONTROL RISK GROUP	CONTROL PROCEDURE CLASS
FIRST FLOOR	103	EXIST RM	RECREATION PAVILION	TYPE B	GROUP 1	CLASS II
FIRST FLOOR	104B	TELECOM ROOM	RECREATION PAVILION	TYPE C	GROUP 1	CLASS II
SEE GENERAL NOTES SHEET FOR CONSTRUCTION INFECTION CONTROL RISK ASSESSMENT (ICRA) DESCRIPTIONS. TYPE, GROUP AND CLASS SELECTED TO BEST OF DESIGN TEAMS KNOWLEDGE. FINAL DETERMINATION BY THE VA WILL BE MADE AT A LATER DATE.						

INFECTION CONTROL RISK ASSESSMENT (ICRA) LEGEND	
	LIMITS OF CONSTRUCTION
	1 HOUR FIRE RATED ICRA / CONSTRUCTION BARRIER LOCATION, AND DOOR, WHERE SHOWN
	TEMPORARY NON-RATED (PLASTIC SHEETING) CONSTRUCTION BARRIER LOCATION, WHERE APPROVED BY THE VA FOR USE IN RISK TYPE B UPGRADE TO 1 HOUR RATED PARTITION WHEN DIRECTED BY THE VA

1 FIRST FLOOR - CONST BARRIER PLAN

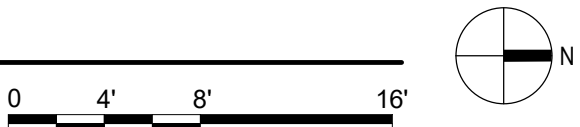

4/21/2022 12:20:13 PM

C:\Users\Public\Documents\Revit Projects\16305-96-R21_E\MarkForLvt

No	REVISION	DATE

CONSULTANT



**SPECIALIZED
ENGINEERING
SOLUTIONS**
10360 Ellipse Circle
Omaha, NE 68134
Phone: 402.991.5520
www.specializedeng.com

ARCHITECT/ENGINEER OF RECORD



ANDERSON
13605 1st Ave. N. #100 Plymouth, MN 55441
P 763.412.4000 | F 763.412.4090 | ae-mn.com
Anderson Engineering of Minnesota, LLC | **Proj # 16305**

STAMP

I hereby certify that this plan, specification or report was prepared by me or under my direct supervision and that I am a duly Licensed Architect under the laws of the State of Minnesota.

Name: 

Typed or Printed Name: Tom Olesak
Date: 03/30/2022 License Number: MN# 18157

DRAWING TITLE

FIRST FLOOR - INFECTION CONTROL & PHASING PLAN

PROJECT TITLE

EHRM INFRASTRUCTURE UPGRADES

BUILDING No

96

CHECKED BY

EM

DRAWN

BMW

LOCATION

VA MEDICAL CENTER
ST. CLOUD, MN 56303

DATE

03/30/2022

PLOT SCALE

PROJECT NO

656-21-235

DRAWING NO

96-GH111


LOCATION

VA MEDICAL CENTER
ST. CLOUD, MN 56303


FULLY SPRINKLERED

DWG. OF

VA



**U.S. Department
of Veterans Affairs**
Veterans Health
Administration
St. Cloud VA
Health Care System

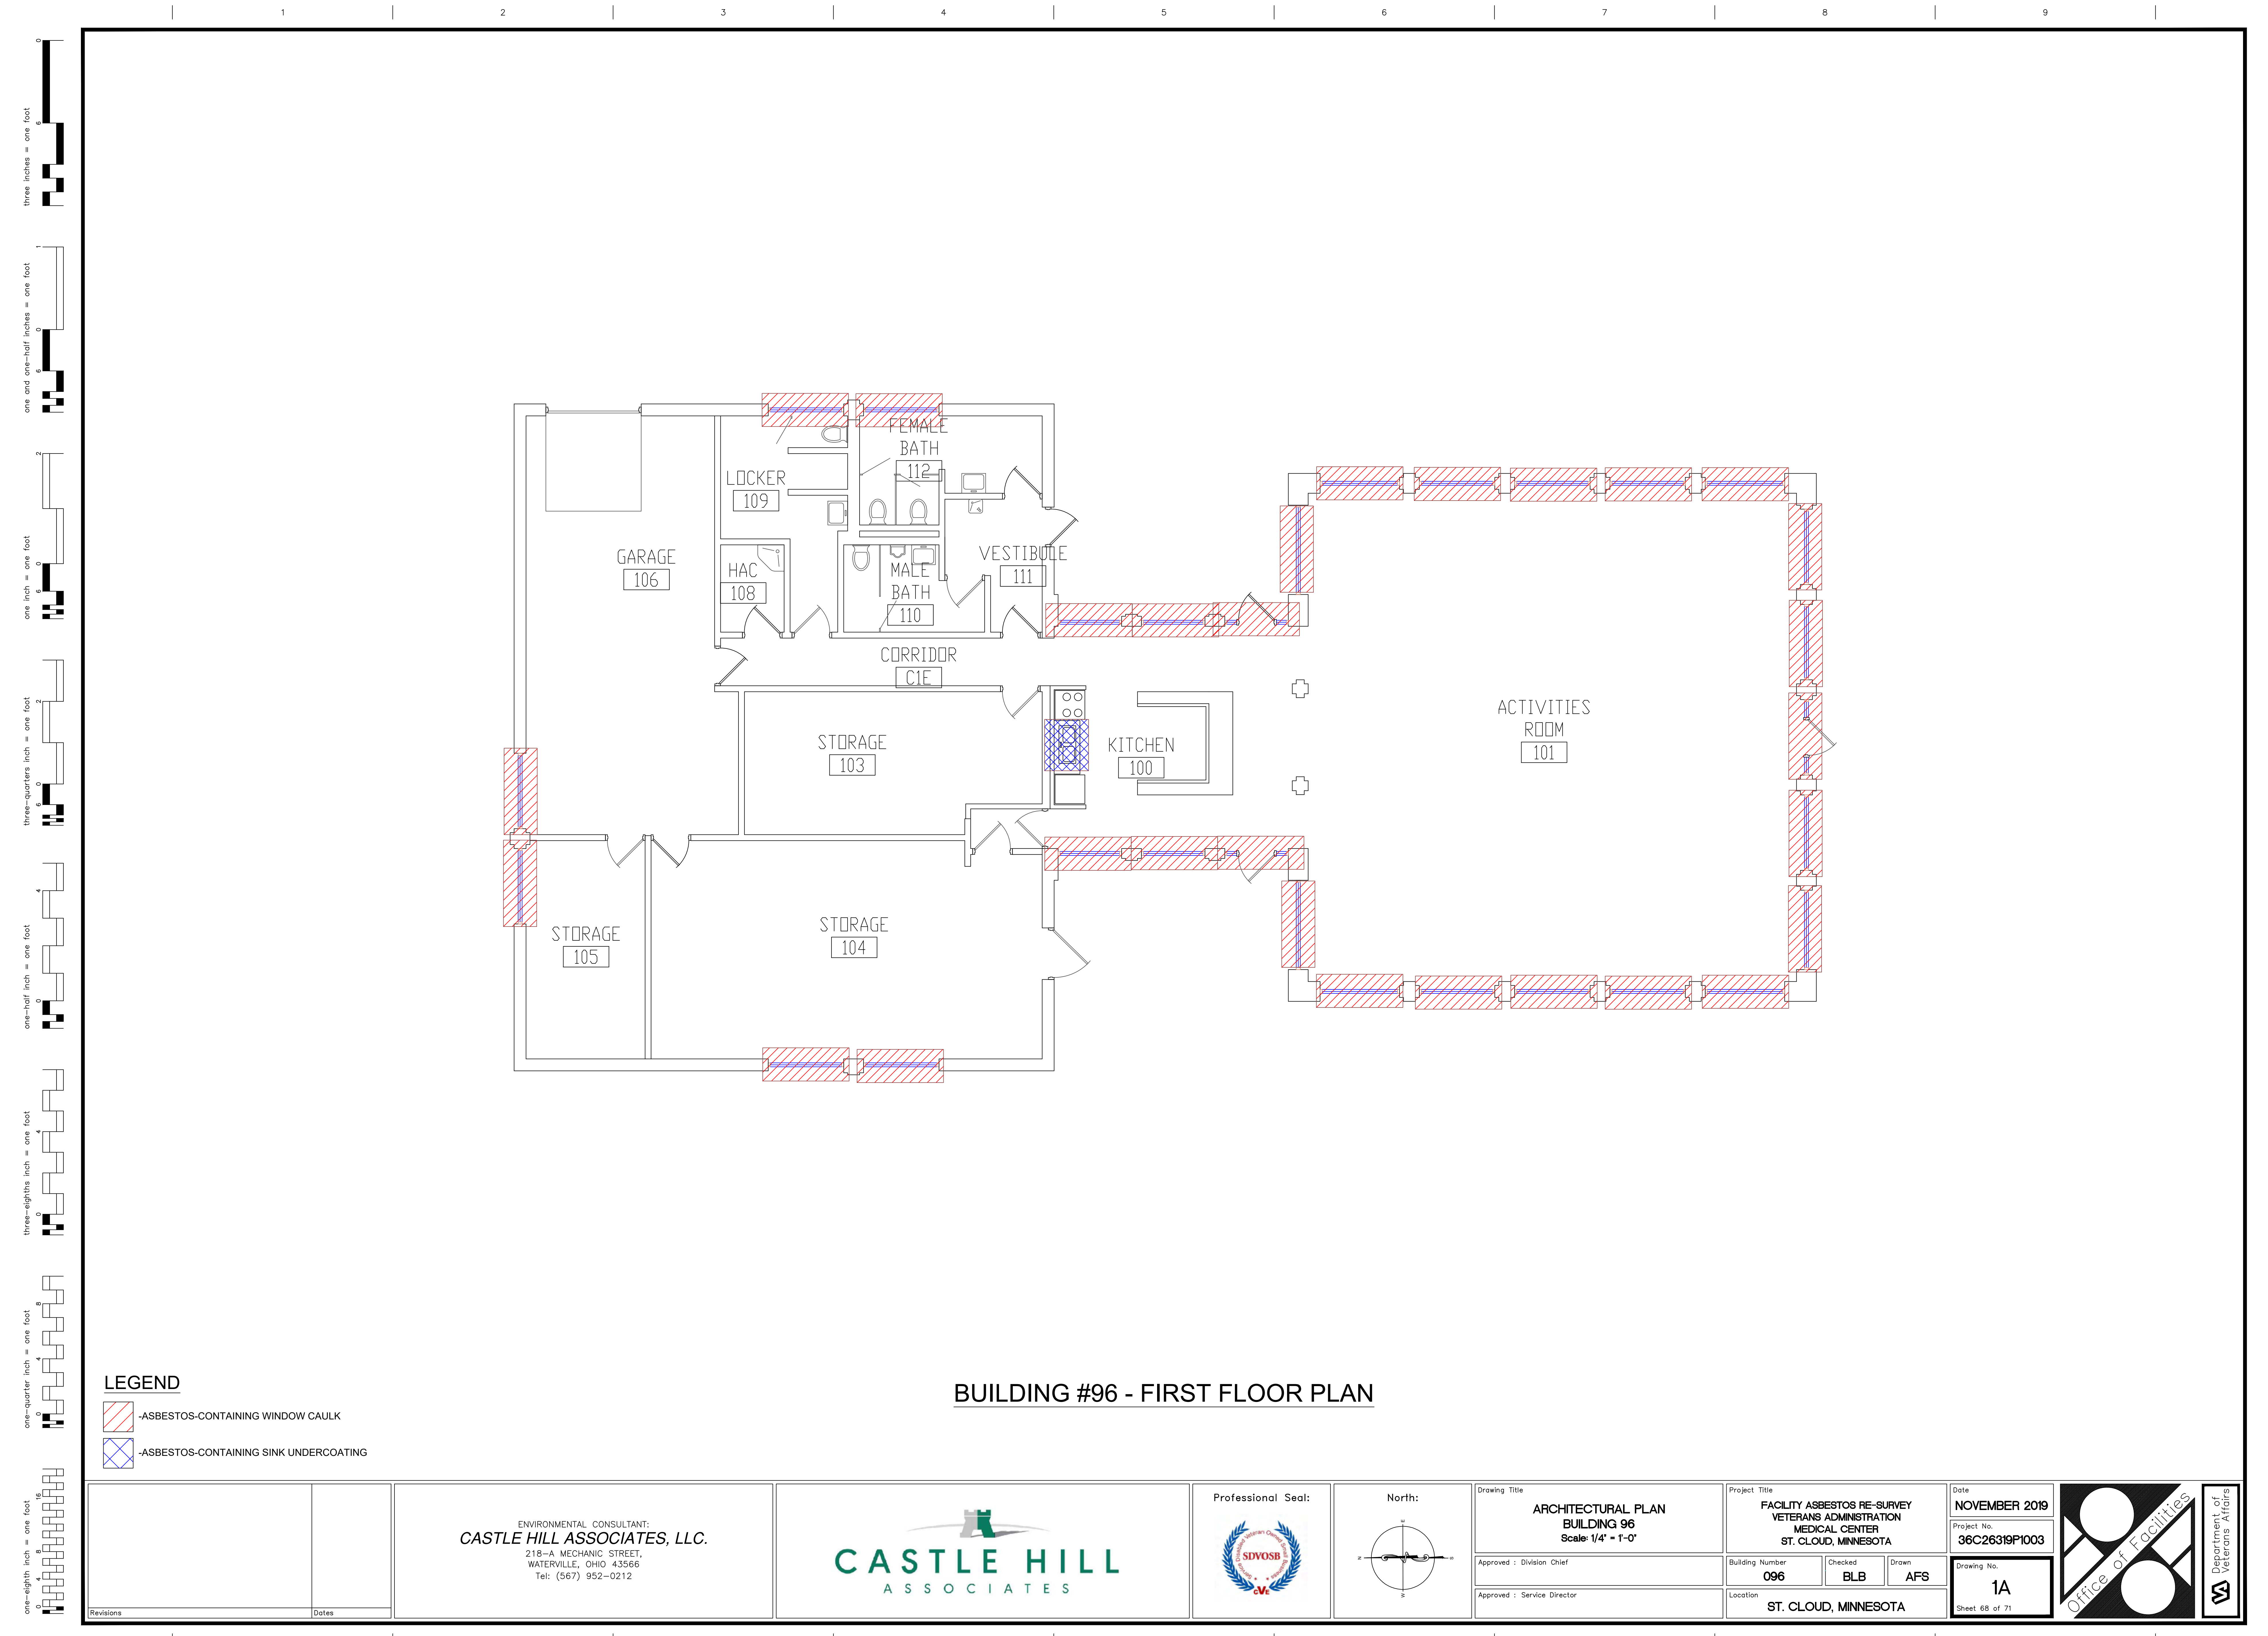


LEGEND

- ASBESTOS-CONTAINING WINDOW CAULK
- ASBESTOS-CONTAINING SINK UNDERCOATING

BUILDING #96 - FIRST FLOOR PLAN

Revisions	Dates	ENVIRONMENTAL CONSULTANT: CASTLE HILL ASSOCIATES, LLC. 218-A MECHANIC STREET, WATERVILLE, OHIO 43566 Tel: (567) 952-0212		Professional Seal: 	North: 	Drawing Title ARCHITECTURAL PLAN BUILDING 96 Scale: 1/4" = 1'-0"	Project Title FACILITY ASBESTOS RE-SURVEY VETERANS ADMINISTRATION MEDICAL CENTER ST. CLOUD, MINNESOTA	Date NOVEMBER 2019	 Office of Facilities	Department of Veterans Affairs 		
						Approved : Division Chief	Building Number 096	Checked BLB			Drawn AFS	Project No. 36C26319P1003
						Approved : Service Director	Location ST. CLOUD, MINNESOTA				Drawing No. 1A	Sheet 68 of 71

4/21/2022 12:20:18 PM
C:\Users\Public\Documents\Revit Projects\16305-96-R21_E\MarkForLvt

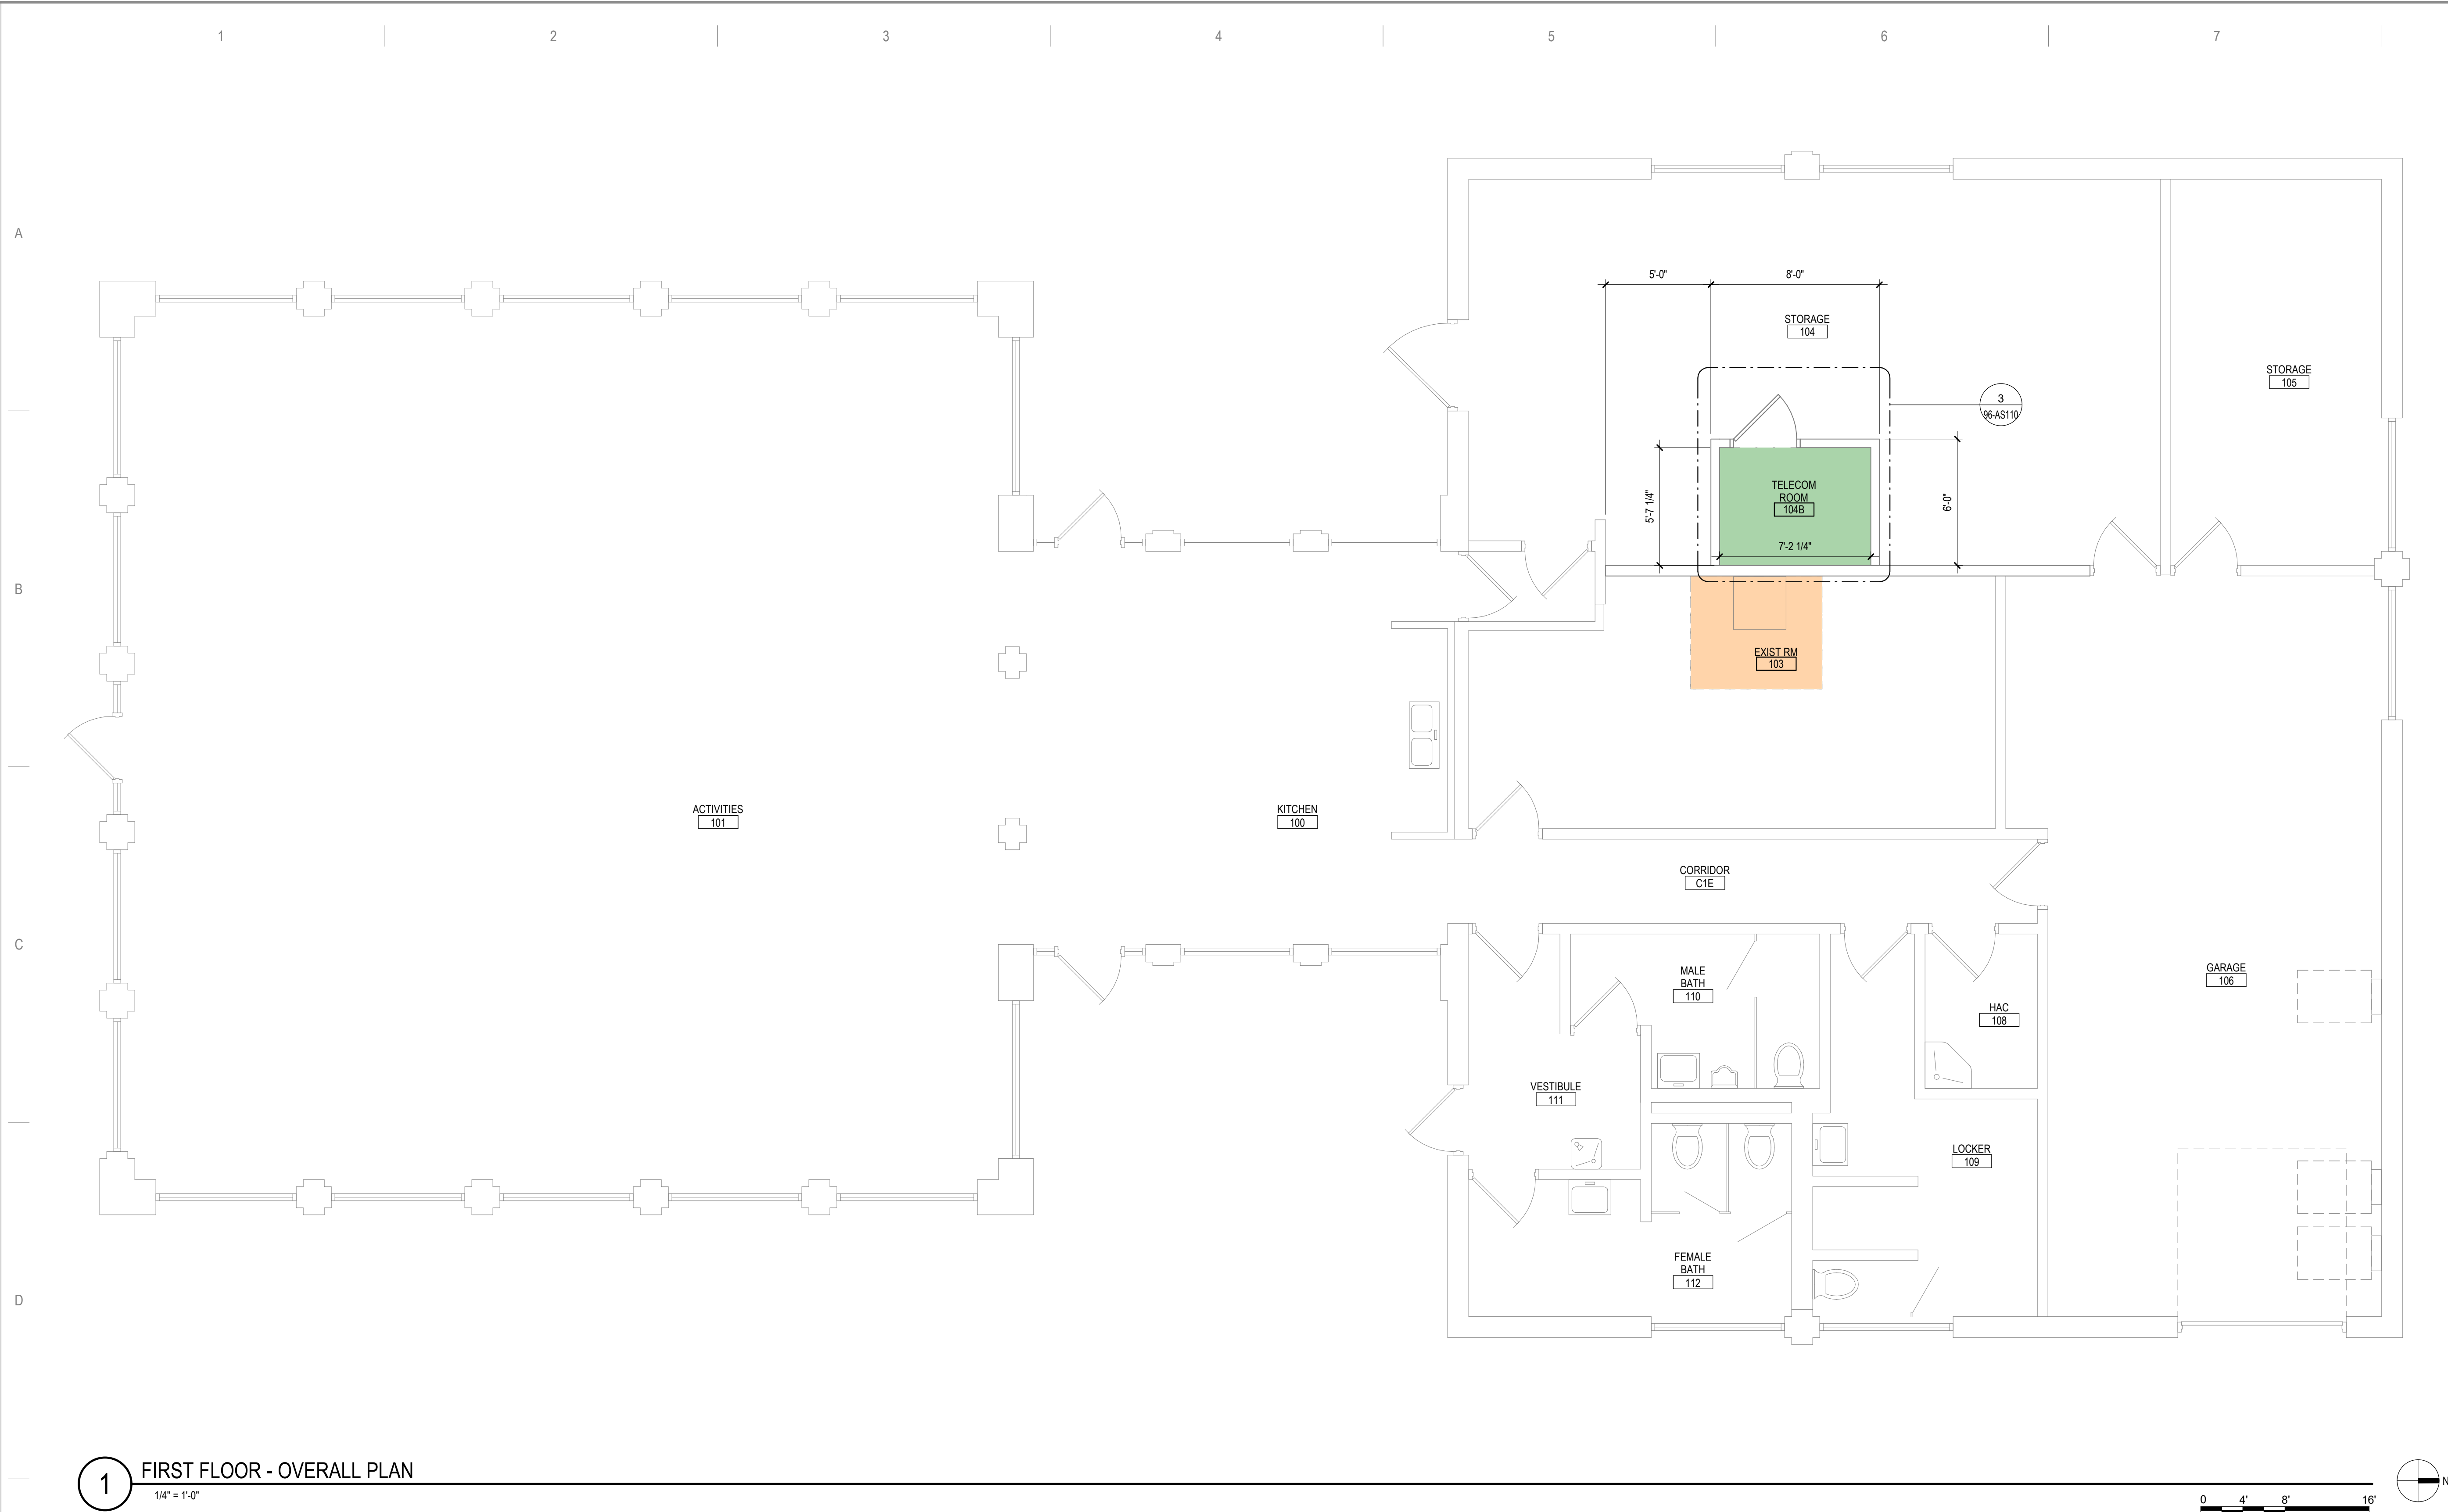

DEMOLITION PLAN KEYED NOTES

DE1 PREPARE WALL FOR PLYWOOD BACKBOARD INSTALLATION AND EHRM REQUIREMENTS. SEE FLOOR PLAN AND TELECOM DRAWINGS

NOTE: NOT ALL KEYED NOTES MAY BE USED ON EACH PLAN

FLOOR PLAN KEYED NOTES

FL1 ALL FOUR PERIMETER WALL PARTITIONS APPLY 4" BY 8" AC GRADE 1/2" TRADE SIZE FIRE RATED PLYWOOD BACKBOARD FINISHED WITH HIGH GLOSS WHITE PAINT OVER TWO COATS OF FIRE RESISTANT PAINT FOR SERVICE PROVIDER SECURITY VIDEO ET CETERA. DO NOT PAINT OVER FIRE RATING STAMP.

FL20 TELECOM EQUIPMENT, SEE TELECOM DRAWINGS

NOTE: NOT ALL KEYED NOTES MAY BE USED ON EACH PLAN


REFLECTED CEILING PLAN KEYED NOTES

RC1 LED LIGHTING, SEE ELECTRICAL IN FRONT OF AND BEHIND CABINET ROWS PROVIDE 500 LUMENS IN HORIZONTAL AND 200 LUMENS IN THE VERTICAL AT 3 FT AFF. OPERATED BY MOTION SENSOR PER CABINET ROW OR SECTION.


NOTE: NOT ALL KEYED NOTES MAY BE USED ON EACH PLAN

SHEET NOTES


- SEE GENERAL NOTES AND CAMPUS DRAWINGS FOR GENERAL INFORMATION, LIFE SAFETY, ICRA, AND PHASING
- ALL EXISTING CONDITIONS MUST BE FIELD VERIFIED BY THE CONTRACTOR PRIOR TO DEMOLITION OR CONSTRUCTION. EXISTING CONDITIONS THAT DIFFER FROM THOSE SHOWN MUST BE BROUGHT TO THE ATTENTION OF THE C.O.R. TO INFORM THE ARCHITECTS AND ENGINEERS.
- THE INFORMATION SHOWN ON THE DRAWINGS IS BASED ON DRAWINGS AND PHOTOGRAPHS PROVIDED BY THE C.O.R. COMBINED WITH OBSERVATIONS AND SURVEYED DATA FROM THE ARCHITECTS AND ENGINEERS.
- SEE CIVIL, STRUCTURAL, TELECOM, ELECTRICAL, MECHANICAL, AND PLUMBING DRAWINGS AND SPECIFICATIONS FOR ADDITIONAL DEMOLITION AND CONSTRUCTION REQUIREMENTS.
- PORTABLE FIRE EXTINGUISHERS (CO2 OR HALOGENATED TYPE AS DETERMINED BY VA) WITH WALL MOUNT BRACKET AND CODE REQUIRED SIGNAGE SHALL BE PROVIDED BY THE CONTRACTOR WITHIN TELECOM ROOMS.

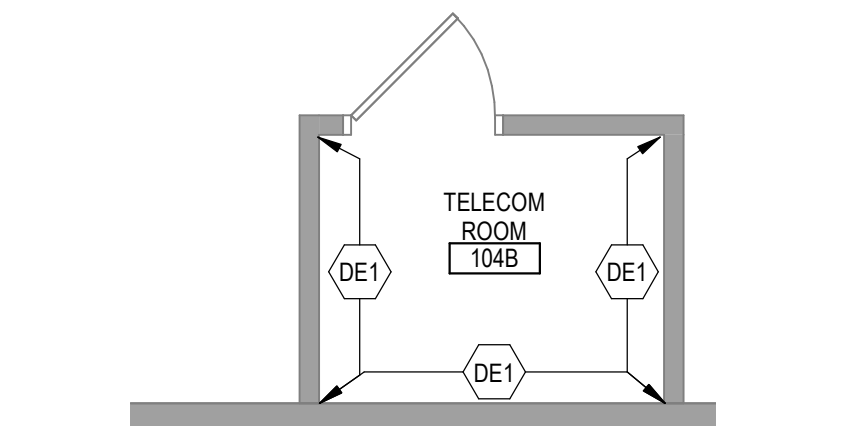

2
1/4" = 1'-0"

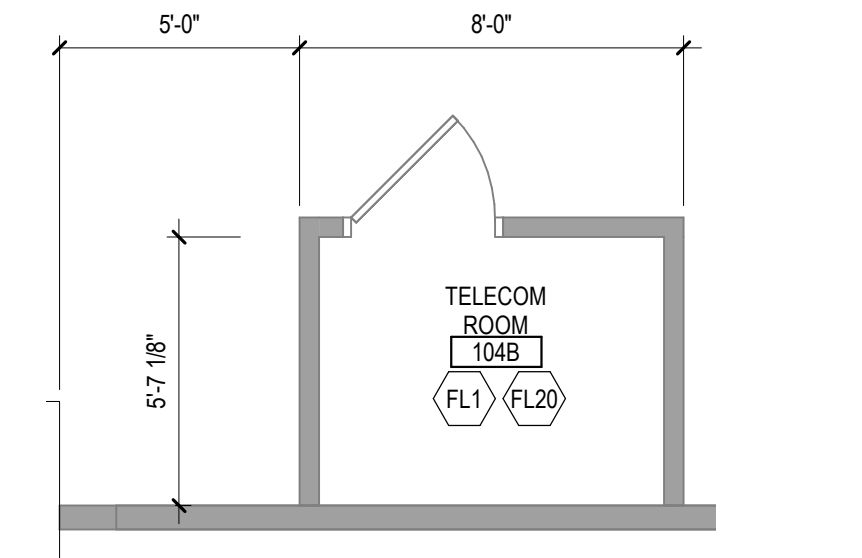

3
1/4" = 1'-0"

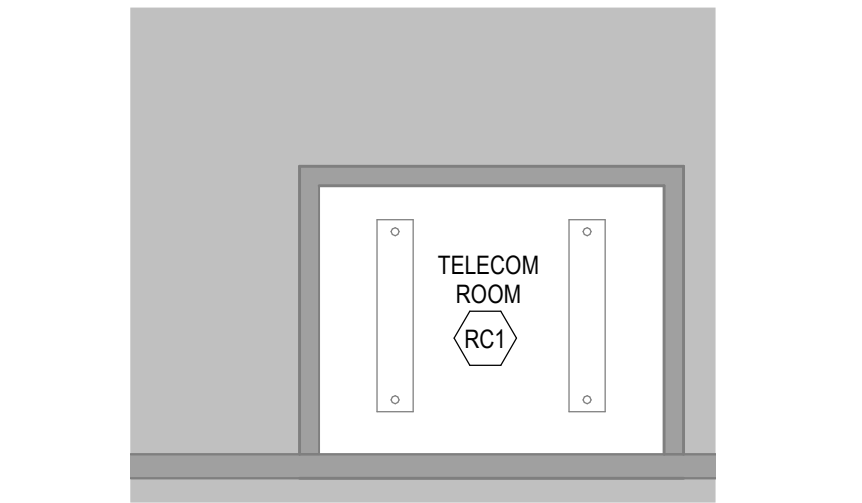

4
1/4" = 1'-0"

No	REVISION	DATE

CONSULTANT

AST SES SPECIALIZED ENGINEERING SOLUTIONS

10360 Ellison Circle
Omaha, NE 68134

Phone: 402.991.5520
www.specializedeng.com

ARCHITECT/ENGINEER OF RECORD

ANDERSON

13605 1st Ave. N. #100 Plymouth, MN 55441
P 763.412.4000 | F 763.412.4090 | ae-mn.com
Anderson Engineering of Minnesota, LLC | Proj # 16305

STAMP

I hereby certify that this plan, specification or report was prepared by me or under my direct supervision and that I am a duly Licensed Architect under the laws of the State of Minnesota.

Name: *Tom Olesak*

Typed or Printed Name: Tom Olesak

Date: 03/30/2022 License Number: MN# 18157

DRAWING TITLE

FIRST FLOOR PLANS


PROJECT FILE	EHRM INFRASTRUCTURE UPGRADES	DATE	03/30/2022
PLOT SCALE	656-21-235	PROJECT NO.	96-AS110
BUILDING NO.	96	CHECKED BY	EM
LOCATION	VA MEDICAL CENTER ST CLOUD, MN 56303	DRAWN BY	EM
LOCATION	VA MEDICAL CENTER ST CLOUD, MN 56303	DATE	03/30/2022
LOCATION	VA MEDICAL CENTER ST CLOUD, MN 56303	DATE	03/30/2022

VA


U.S. Department of Veterans Affairs

Veterans Health Administration

St. Cloud VA Health Care System

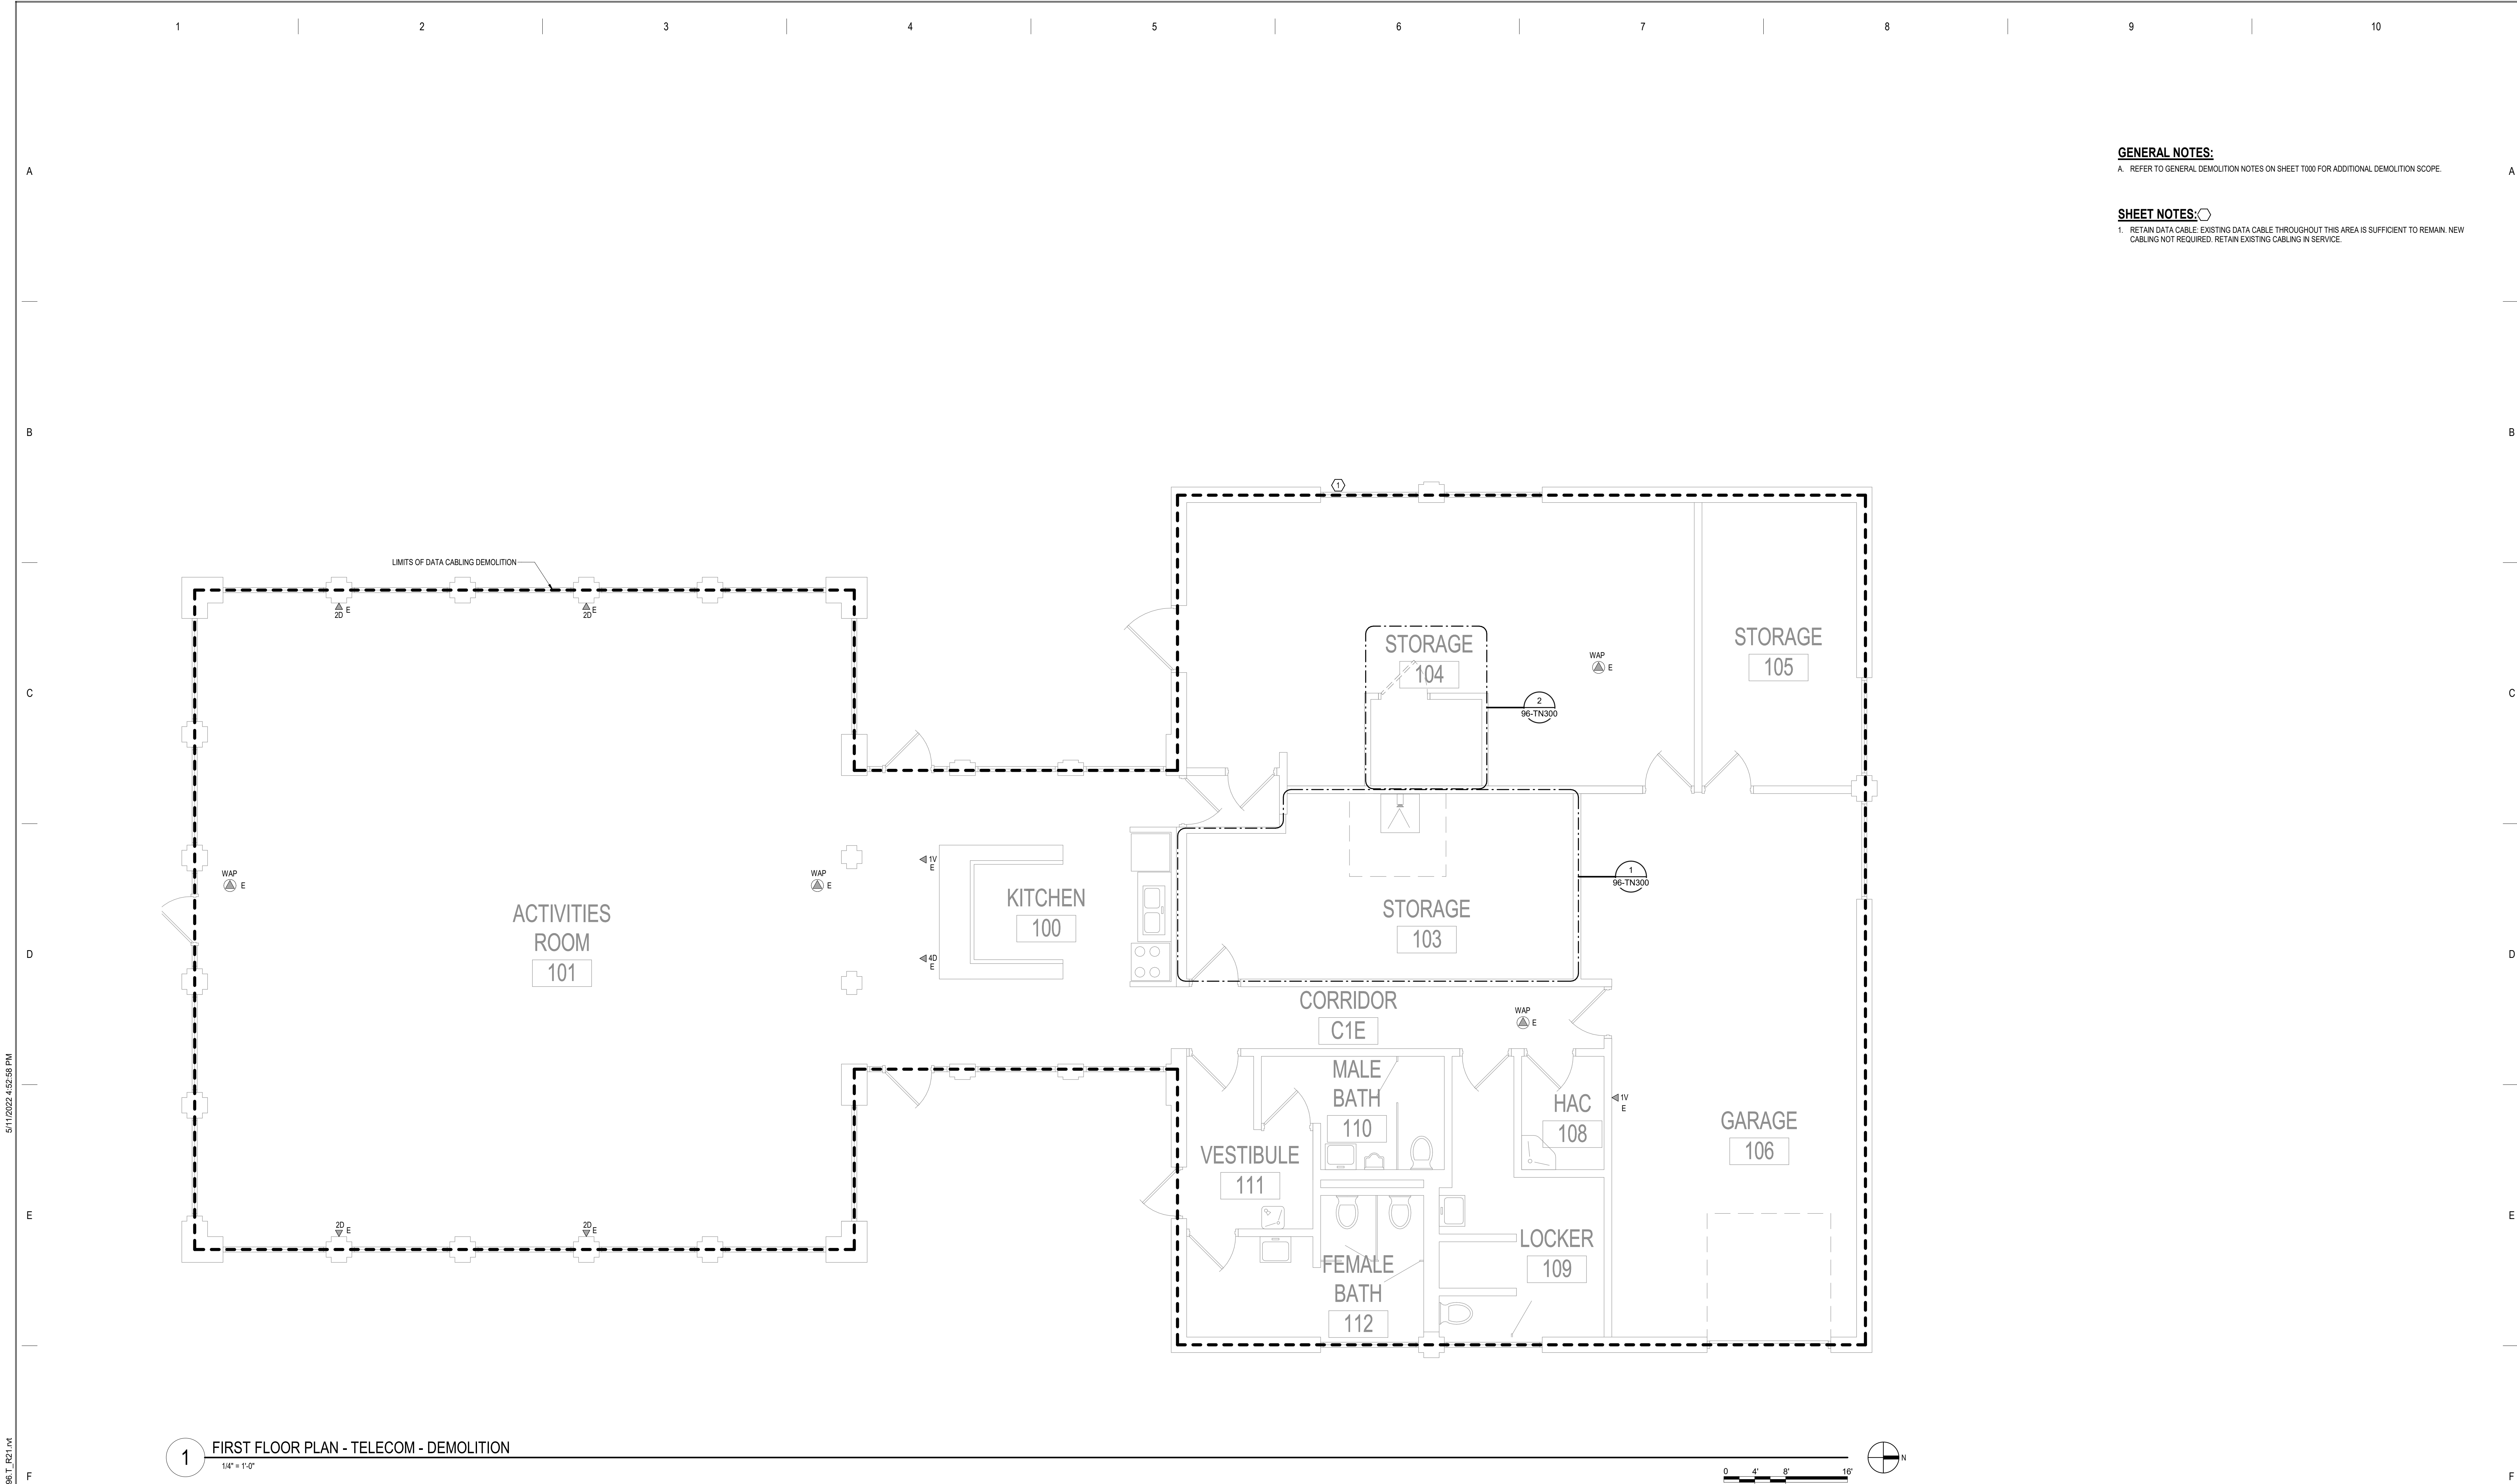


BIM 350 / 21.02.102.102		

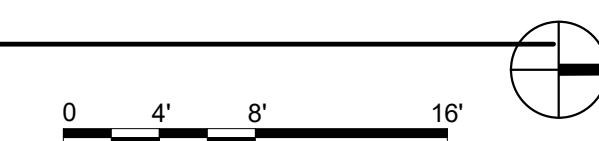

VA |  **U.S. Department
of Veterans Affairs**
Veterans Health
Administration
St. Cloud VA
Health Care System

F

三

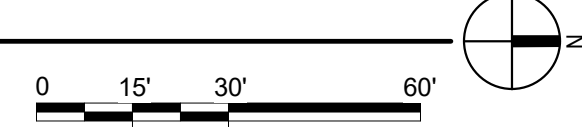

1

VA |  **U.S. Department
of Veterans Affairs**
Veterans Health
Administration
St. Cloud VA
Health Care System

B:\M 360\21\02\001 - VA St Cloud EHRM Infrastructure Upgrades\656-235 B86.T_R21.dwg 5/11/2022 4:53:02 PM

No	REVISION	DATE

CONSULTANT

AST

SES

SPECIALIZED
ENGINEERING
SOLUTIONS

10360 Ellison Circle
Omaha, NE 68134

Phone: 402.991.5520
www.specializedeng.com

ARCHITECT/ENGINEER OF RECORD

ANDERSON

13605 1st Ave. N. #100 Plymouth, MN 55441
P 763.412.4000 | F 763.412.4090 | ae-mn.com
Anderson Engineering of Minnesota, LLC | Proj # 16305

STAMP

REGISTERED COMMUNICATIONS DISTRIBUTION

Bicsi

Nathan Timm

BICS1 ID # 346555

EXPIRES 12-31-24

Signature

Nathan M. Timm

DRAWING TITLE

ENLARGED PLANS -
TELECOMMUNICATIONS -
DEMO

PROJECT TITLE

EHRM INFRASTRUCTURE
UPGRADES

DATE

03/30/2022

PLOT SCALE

PROJECT NO.

656-21-235

DRAWING NO.

96-TN300

BUILDING NO.

96

CHECKED BY

KSB

DRAWN

SSK

LOCATION

VA MEDICAL CENTER
ST. CLOUD, MN 56303

FULLY
SPRINKLERED

DWG. OF

VA

U.S. Department
of Veterans Affairs

Veterans Health
Administration

St. Cloud VA
Health Care System

GENERAL NOTES:

A. REFER TO GENERAL DEMOLITION NOTES ON SHEET T000 FOR ADDITIONAL DEMOLITION SCOPE.

SHEET NOTES:

1. 2 POST RACK TO REMAIN IN ROOM 104B. DATA RACKS CAN BE REMOVED FROM ROOM 103.

CABLING NOTE:

CABLING NOTES:

A. THE EXISTING CABLE COUNT ARE THE CABLES CURRENTLY PRESENT IN THE SPACE. THE CABLE RELOCATION COUNT ARE THE NEW OR RELOCATED CABLES TO BE FED FROM THE SPACE. THE FINAL CABLE COUNT ARE THE CABLES THAT WILL BE PRESENT IN THE SPACE AT THE COMPLETION OF THE PROJECT.


1. ROOM 103
EXISTING CABLE COUNT
DATA (CAT6): 20
DATA (CAT5e): 0
DATA (CAT5): 0
DATA (CAT3): 0

CABLE RELOCATION COUNT
DATA (CAT6): 0
DATA (CAT5e): 0
DATA (CAT5): 0
DATA (CAT3): 0

EXISTING CABLE TO REMAIN
DATA (CAT6): 0
DATA (CAT5e): 0
DATA (CAT5): 0
DATA (CAT3): 0

FINAL CABLE COUNT
DATA (CAT6): 20
DATA (CAT5e): 0
DATA (CAT5): 0
DATA (CAT3): 0

BIM 360://21102.001 - VA St Cloud EHRM Infrastructure Upgrades/656-235 B66_T_R21.rvt 5/11/2022 4:53:04 PM

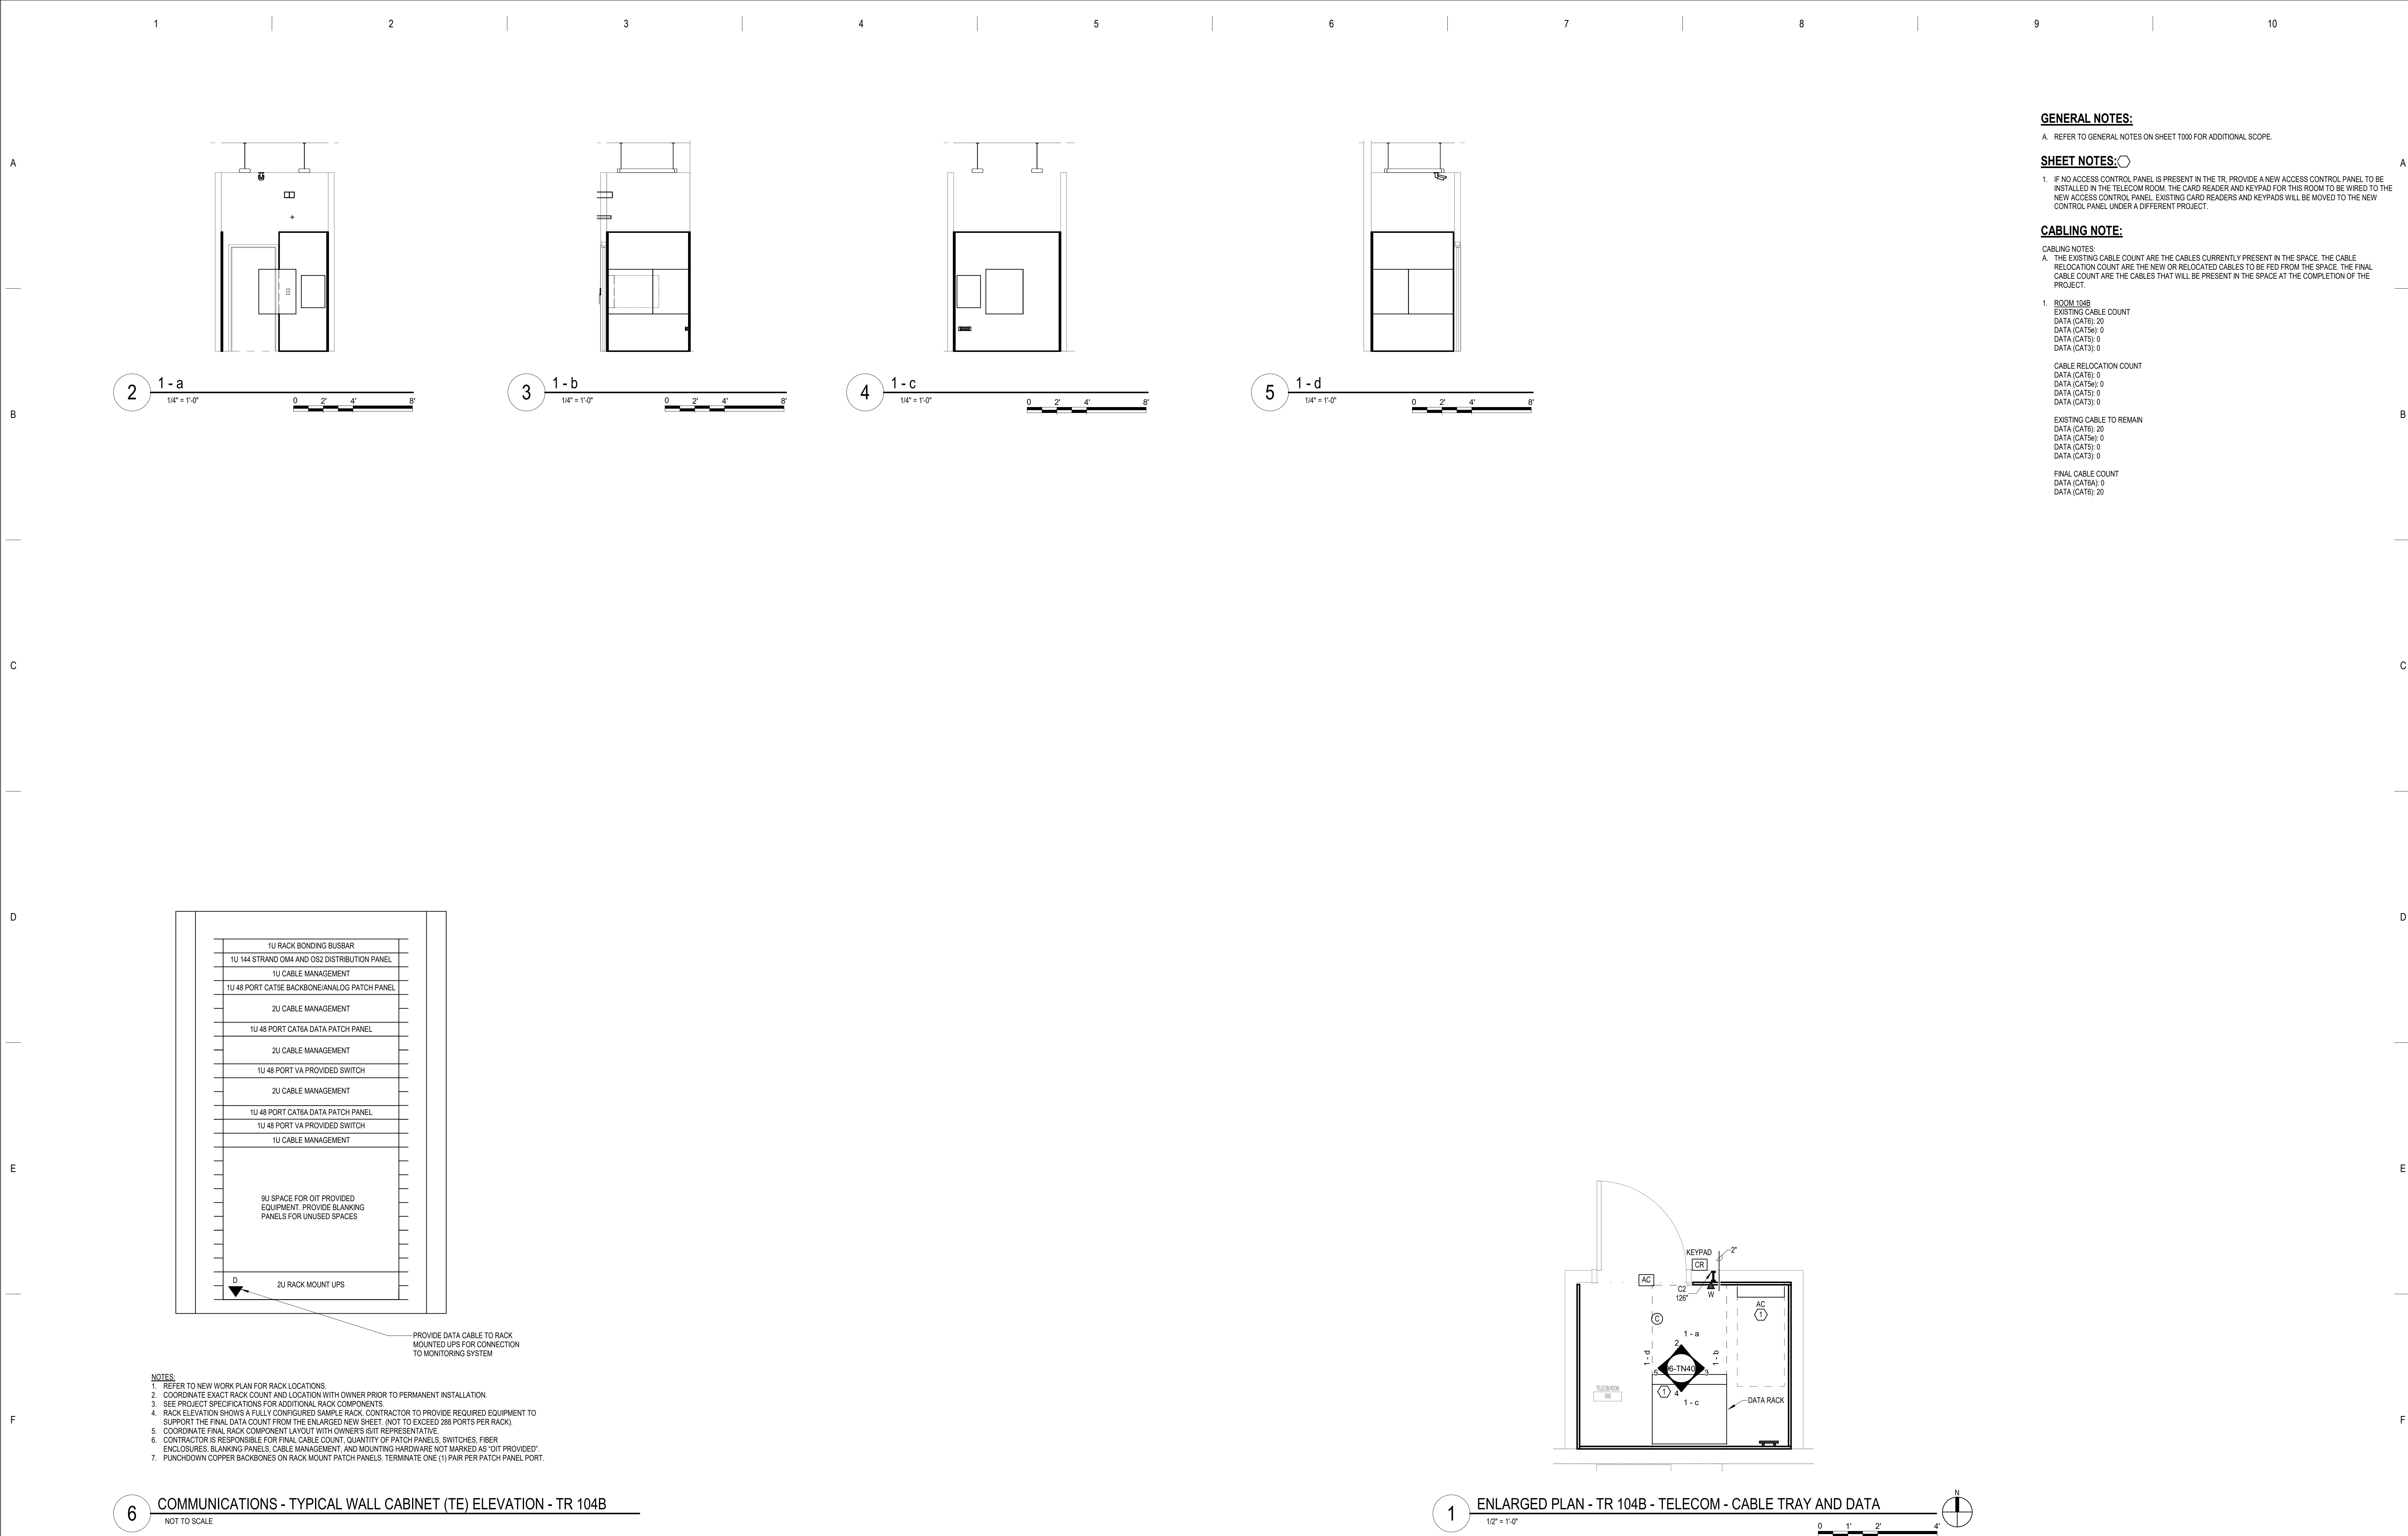

<table><tr><td>No</td><td>REVISION</td><td>DATE</td></tr><tr><td> </td><td> </td><td> </td></tr><tr><td> </td><td> </td><td> </td></tr><tr><td> </td><td> </td><td> </td></tr><tr><td> </td><td> </td><td> </td></tr><tr><td> </td><td> </td><td> </td></tr><tr><td> </td><td> </td><td> </td></tr><tr><td> </td><td> </td><td> </td></tr><tr><td> </td><td> </td><td> </td></tr><tr><td> </td><td> </td><td> </td></tr></table>	No	REVISION	DATE																												<table><tr><td>CONSULTANT</td></tr><tr><td>AST SES SPECIALIZED ENGINEERING SOLUTIONS</td></tr><tr><td>10360 Ellison Circle Omaha, NE 68134 Phone: 402.991.5520 www.specializedeng.com</td></tr></table>	CONSULTANT	AST SES SPECIALIZED ENGINEERING SOLUTIONS	10360 Ellison Circle Omaha, NE 68134 Phone: 402.991.5520 www.specializedeng.com	<table><tr><td>ARCHITECT/ENGINEER OF RECORD</td></tr><tr><td>ANDERSON</td></tr><tr><td>13605 1st Ave. N. #100 Plymouth, MN 55441 P 763.412.4000 F 763.412.4090 ae-mn.com Anderson Engineering of Minnesota, LLC Proj # 16305</td></tr></table>	ARCHITECT/ENGINEER OF RECORD	ANDERSON	13605 1st Ave. N. #100 Plymouth, MN 55441 P 763.412.4000 F 763.412.4090 ae-mn.com Anderson Engineering of Minnesota, LLC Proj # 16305	<table><tr><td>STAMP</td></tr><tr><td>REGISTERED COMMUNICATIONS DISTRIBUTION</td></tr><tr><td>Bicsi Nathan Timm BICS1 ID # 346555 Expires 12-31-24</td></tr><tr><td><i>Nathan M. Timm</i></td></tr></table>	STAMP	REGISTERED COMMUNICATIONS DISTRIBUTION	Bicsi Nathan Timm BICS1 ID # 346555 Expires 12-31-24	<i>Nathan M. Timm</i>	<table><tr><td>DRAWING TITLE</td></tr><tr><td>ENLARGED PLANS - TELECOMMUNICATIONS</td></tr></table>	DRAWING TITLE	ENLARGED PLANS - TELECOMMUNICATIONS	<table><tr><td>PROJECT FILE</td></tr><tr><td>EHRM INFRASTRUCTURE UPGRADES</td></tr><tr><td>DATE 03/30/2022</td></tr><tr><td>PLOT SCALE</td></tr><tr><td>PROJECT NO. 656-21-235</td></tr><tr><td>DRAWING NO. 96-TN400</td></tr><tr><td>BUILDING NO. 96</td></tr><tr><td>CHECKED BY KSB</td></tr><tr><td>DRAWN SSK</td></tr><tr><td>LOCATION VA MEDICAL CENTER ST. CLOUD, MN 56303</td></tr><tr><td>FULLY SPRINKLERED</td></tr><tr><td>DWG. OF</td></tr></table>	PROJECT FILE	EHRM INFRASTRUCTURE UPGRADES	DATE 03/30/2022	PLOT SCALE	PROJECT NO. 656-21-235	DRAWING NO. 96-TN400	BUILDING NO. 96	CHECKED BY KSB	DRAWN SSK	LOCATION VA MEDICAL CENTER ST. CLOUD, MN 56303	FULLY SPRINKLERED	DWG. OF	<table><tr><td>VA</td></tr><tr><td>U.S. Department of Veterans Affairs Veterans Health Administration St. Cloud VA Health Care System</td></tr></table>	VA	U.S. Department of Veterans Affairs Veterans Health Administration St. Cloud VA Health Care System
No	REVISION	DATE																																																												
CONSULTANT																																																														
AST SES SPECIALIZED ENGINEERING SOLUTIONS																																																														
10360 Ellison Circle Omaha, NE 68134 Phone: 402.991.5520 www.specializedeng.com																																																														
ARCHITECT/ENGINEER OF RECORD																																																														
ANDERSON																																																														
13605 1st Ave. N. #100 Plymouth, MN 55441 P 763.412.4000 F 763.412.4090 ae-mn.com Anderson Engineering of Minnesota, LLC Proj # 16305																																																														
STAMP																																																														
REGISTERED COMMUNICATIONS DISTRIBUTION																																																														
Bicsi Nathan Timm BICS1 ID # 346555 Expires 12-31-24																																																														
<i>Nathan M. Timm</i>																																																														
DRAWING TITLE																																																														
ENLARGED PLANS - TELECOMMUNICATIONS																																																														
PROJECT FILE																																																														
EHRM INFRASTRUCTURE UPGRADES																																																														
DATE 03/30/2022																																																														
PLOT SCALE																																																														
PROJECT NO. 656-21-235																																																														
DRAWING NO. 96-TN400																																																														
BUILDING NO. 96																																																														
CHECKED BY KSB																																																														
DRAWN SSK																																																														
LOCATION VA MEDICAL CENTER ST. CLOUD, MN 56303																																																														
FULLY SPRINKLERED																																																														
DWG. OF																																																														
VA																																																														
U.S. Department of Veterans Affairs Veterans Health Administration St. Cloud VA Health Care System																																																														

A

B


C

D


E

F


- KEYNOTES: (E)**
1. DISCONNECT AND REMOVE LIGHTS AND RECEPTACLES IN AREA OF NEW IT ROOM. MAINTAIN CIRCUIT CONTINUITY TO ADJOINING SPACES.
 2. COORDINATE FINAL LOCATION OF QUADPLEX RECEPTACLE WITH TELECOM CONTRACTOR.
 3. CONNECT SMOKE DETECTOR TO NEAREST EXISTING SLC.
 4. PROVIDE ELECTRICAL CONNECTION TO CONDENSING UNIT, AS REQUIRED. COORDINATE FINAL LOCATION AND CONNECTION REQUIREMENTS WITH MECHANICAL.

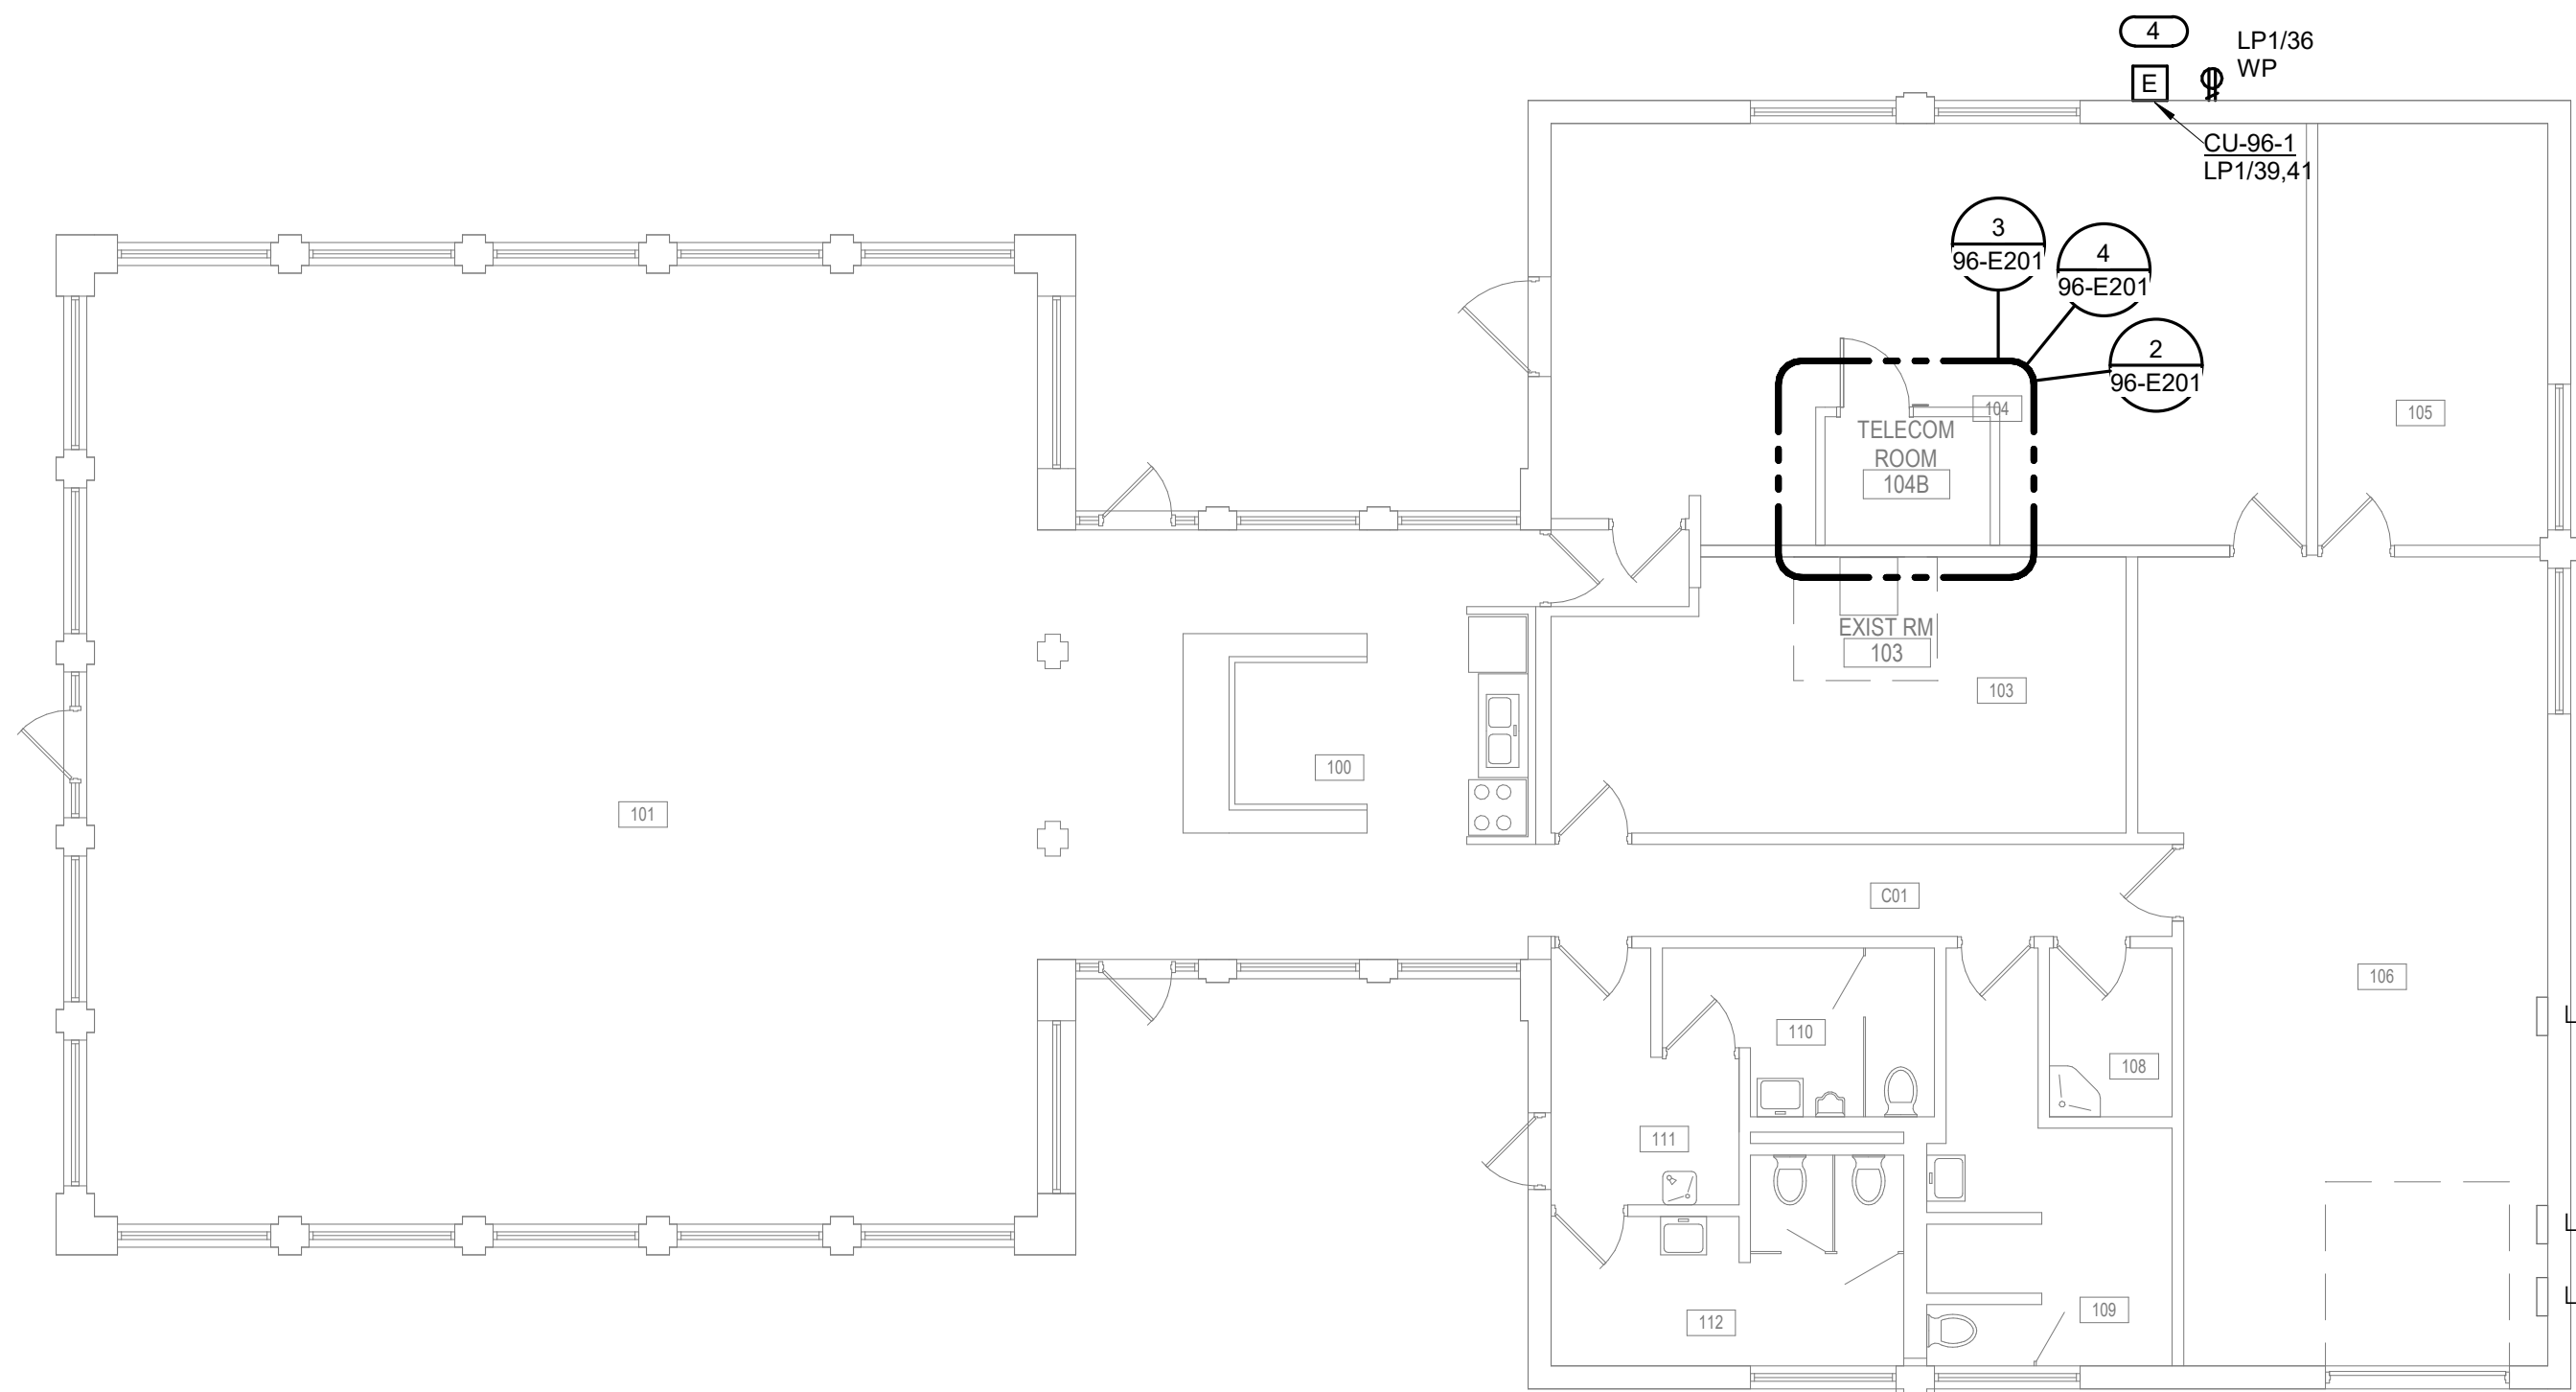


1 FIRST FLOOR PLAN - ELECTRICAL
1/8" = 1'-0"

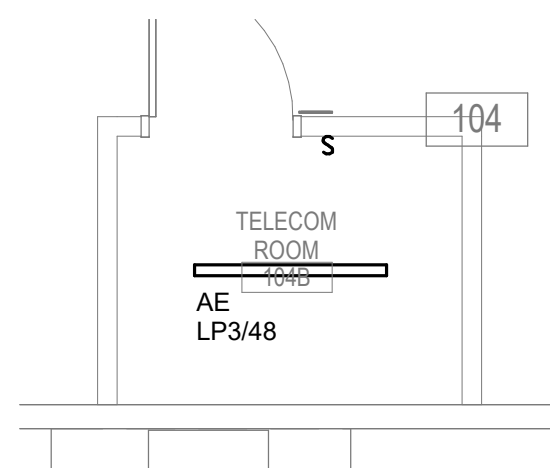

2 FIRST FLOOR PLAN - TR 104B - LIGHTING
1/4" = 1'-0"

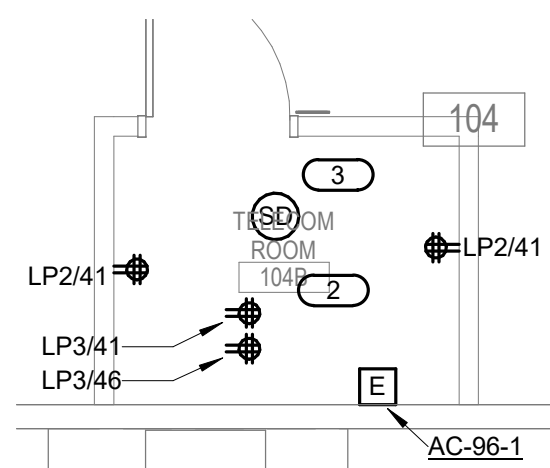

3 FIRST FLOOR PLAN - TR 104B - POWER AND SYSTEM
1/4" = 1'-0"

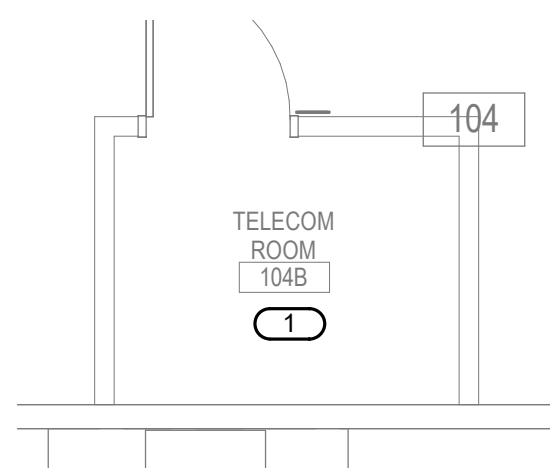

4 FIRST FLOOR PLAN - TR 104B - ELECTRICAL DEMOLITION
1/4" = 1'-0"



5/11/2022 5:56:44 PM

B:\360\21\102\101 - VA St Cloud EHRM Infrastructure Upgrades\656-235 B96.E_R21.dwg

No	100% CD	REVISION	DATE
			03/30

CONSULTANT

AST SES SPECIALIZED ENGINEERING SOLUTIONS

10360 Ellison Circle
Omaha, NE 68134

Phone: 402.991.5520
www.specializedeng.com

ARCHITECT/ENGINEER OF RECORD

ANDERSON

13605 1st Ave. N. #100 Plymouth, MN 55441
P 763.412.4000 | F 763.412.4090 | ae-mn.com
Anderson Engineering of Minnesota, LLC | Proj # 16305

STAMP

LICENSURE PROFESSIONAL ENGINEER
50009
05-06-2022

DRAWING TITLE

FIRST FLOOR PLAN - ELECTRICAL

PROJECT FILE	DATE
EHRM INFRASTRUCTURE UPGRADES	03/30/2022
PLOT SCALE	
PROJECT NO.	656-21-235
BUILDING NO.	96
CHECKED BY	TBD
DRAWN	GJL
DRAWING NO.	96-E201
LOCATION	VA MEDICAL CENTER ST. CLOUD, MN 56303
FULLY SPRINKLERED	DWG. OF

VA

U.S. Department of Veterans Affairs

Veterans Health Administration
St. Cloud VA Health Care System