

GENERAL NOTES:

1. SHEET SIZE FOR PROPER SCALE IS 30X42. CONTRACTOR SHALL NOT SCALE DRAWINGS BUT SHALL REQUEST THE DESIRED DIMENSIONS FROM THE ARCHITECT.
2. SEE SHEET G-002 FOR GENERAL NOTES.
3. APPLY 1 1/2" THICK FIREPROOFING AT ALL EXPOSED STEEL WITHIN INTERSTITIAL SPACE AND AT EXPOSED STEEL STRUCTURE ABOVE 3RD FLOOR CEILING, TYP.

SHEET SPECIFIC NOTES:

1. REFERENCE STRUCTURAL FOR STAIR DETAILS.
2. ALL STRUCTURAL STEEL AND TUBING IS TO BE PAINTED. SEE STRUCTURAL REFERENCE 099000.

10 ENLARGED STAIR FLOOR PLAN - LEVEL 1
1/4" = 1'-0"

1 ENLARGED STAIR FLOOR PLAN - LEVEL 2
1/4" = 1'-0"

2 ENLARGED STAIR FLOOR PLAN - LEVEL 3
1/4" = 1'-0"

3 STAIRSECTION
1/4" = 1'-0"

5 TYPICAL STAIR LANDING SECTION
1" = 1'-0"

4 STAIRSECTION
1/4" = 1'-0"

6 TYPICAL STAIR RAIL SECTION
1" = 1'-0"

9 STAIR - GUARD AT CENTER OF FIGHT
1 1/2" = 1'-0"

8 TYPICAL HANDRAIL DETAIL
3" = 1'-0"

7 TYPICAL STAIR SECTION
1 1/2" = 1'-0"

CONSTRUCTION DOCUMENTS

CONSULTANTS:



TERRASITE DESIGN
1635 DEADWOOD AVENUE
RAPID CITY, SOUTH DAKOTA 57702
PH: (605) 791-1736



Albertson Engineering, Inc.

ALBERTSON ENGINEERING, INC.
315 NORTH MAIN AVENUE, SUITE 200
SIOUX FALLS, SOUTH DAKOTA 57104
PH: (605) 274-0880



FARRIS ENGINEERING
OMAHA (BRICKS) (BENT) (COUNCIL) (PENG)
RAPID CITY, SOUTH DAKOTA 57702
PH: (605) 791-1736

FARRIS ENGINEERING
12700 WEST DODGE ROAD
OMAHA, NEBRASKA 68154
PH: (402) 330-5900



ARCHITECT



FOURFRONT DESIGN, INC.
517 7TH STREET
RAPID CITY, SOUTH DAKOTA
57701
PH: (605) 342-9470
FAX: (605) 342-2377
WWW.FOURFRONTDESIGN.COM

Drawing Title

ENLARGED STAIR PLANS, SECTIONS
AND DETAILS

Approved: Project Director

Omaha VA Medical Center

Project Title

Design/Construct Sterile
Processing Service- Omaha VA
Medical Center

Location 4101 Woolworth Ave #4199
Omaha, Ne 68105

Date 11/23/2020

Checked JL

Drawn JGC

Project Number

16.2330.A08

Building Number

25

Drawing Number

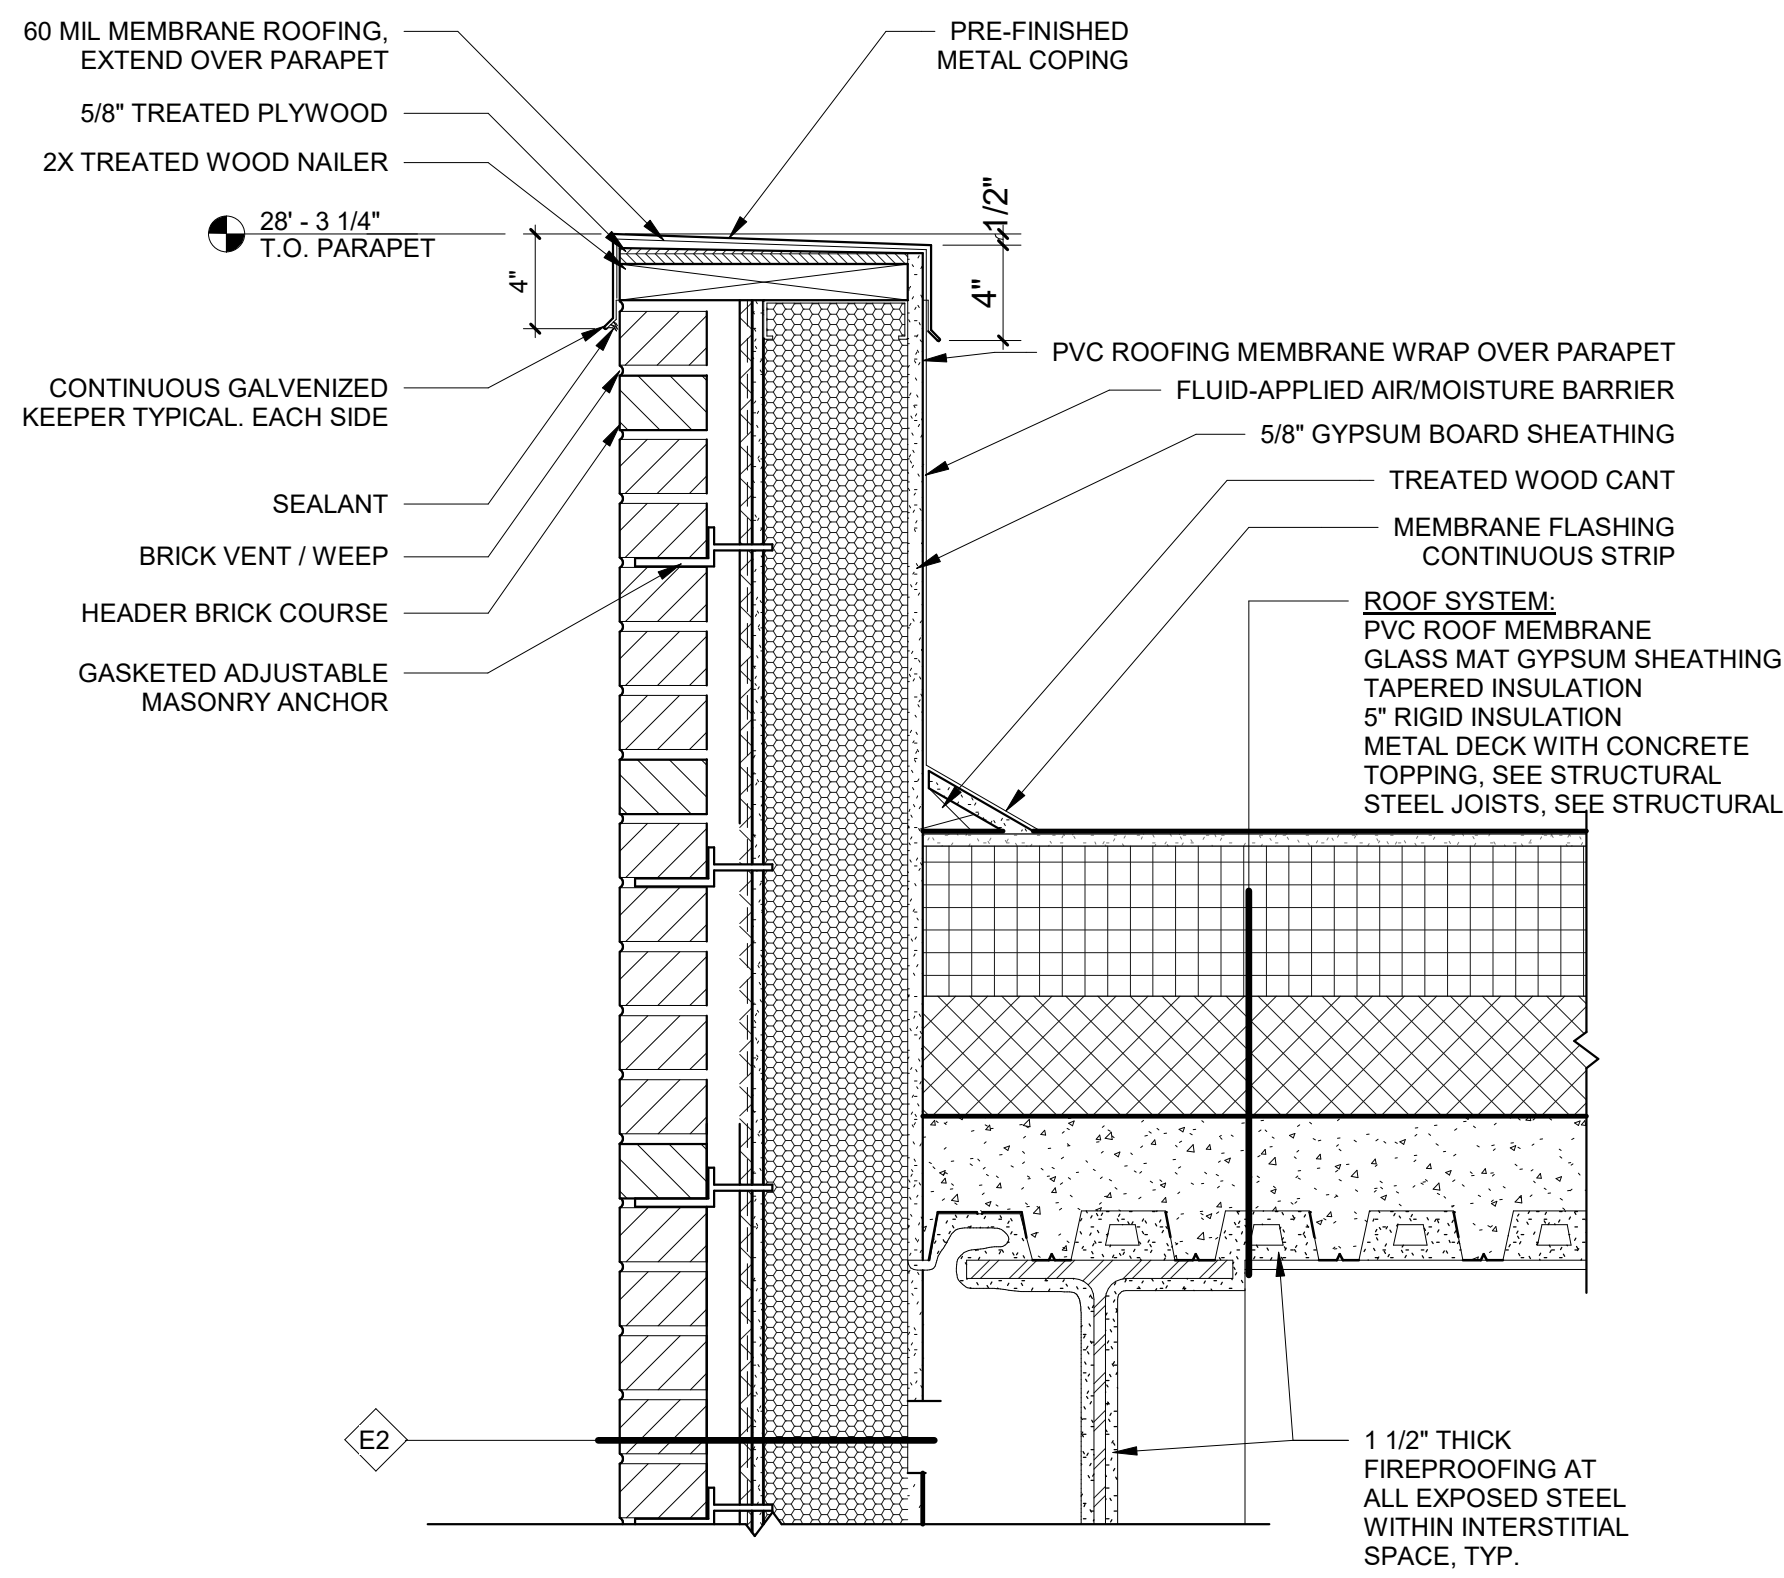
A-400

Dwg. 57 of 193


Office of
Construction
and Facilities
Management




Department of
Veterans Affairs




1 PARAPET DETAIL
1 1/2" = 1'-0"

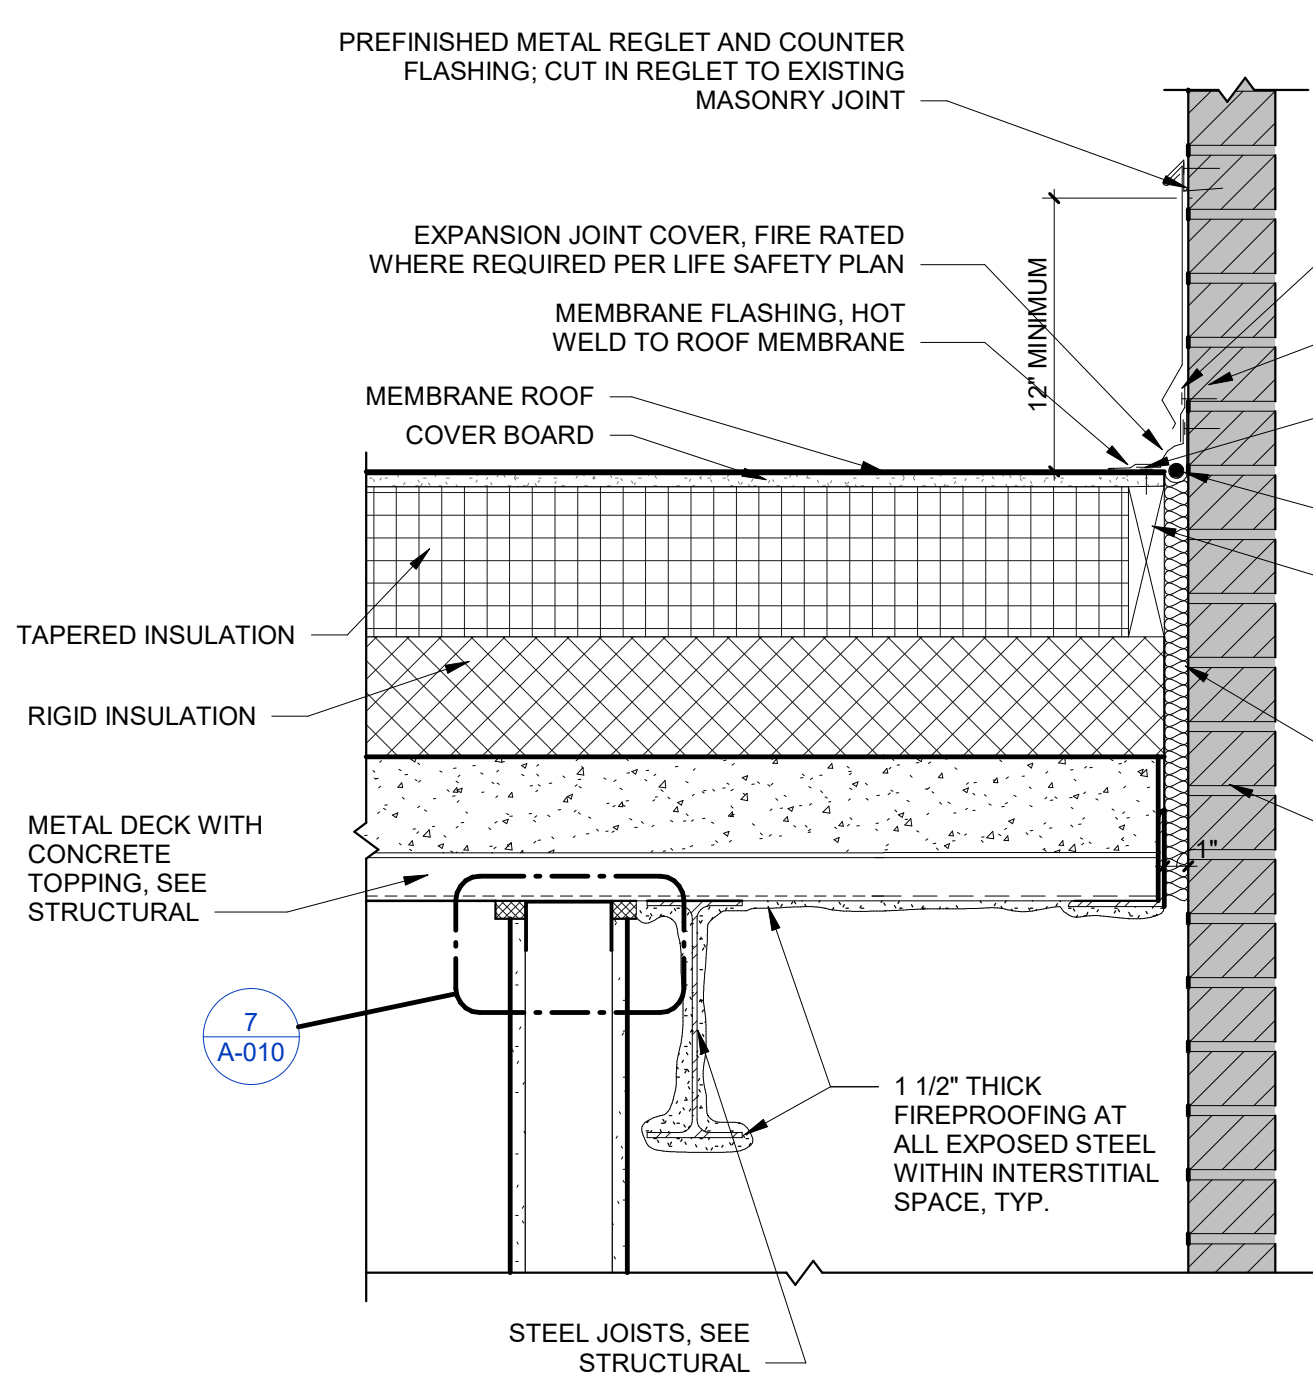

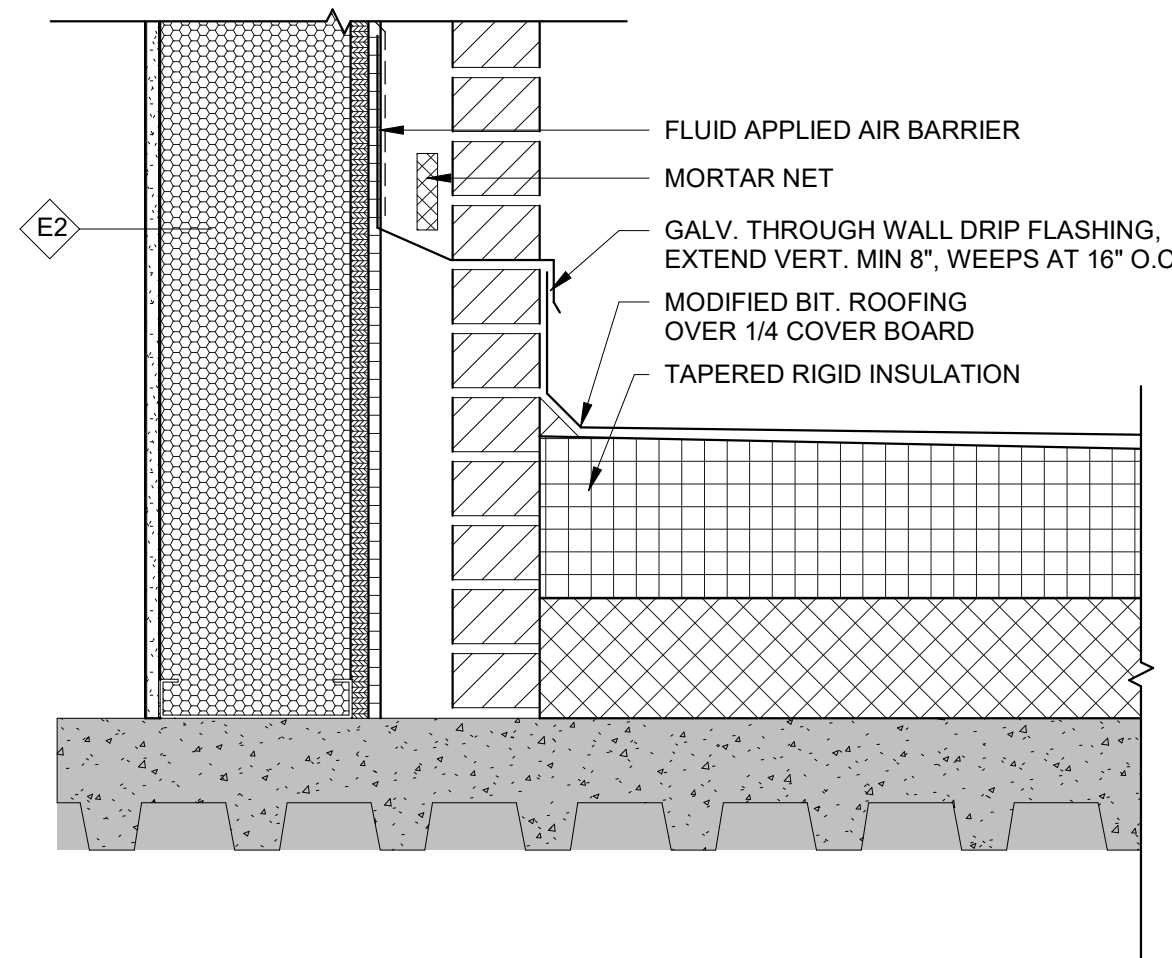
2 ROOF DETAIL HIGH - EXPANSION JOINT AT EXISTING WALL
1 1/2" = 1'-0"



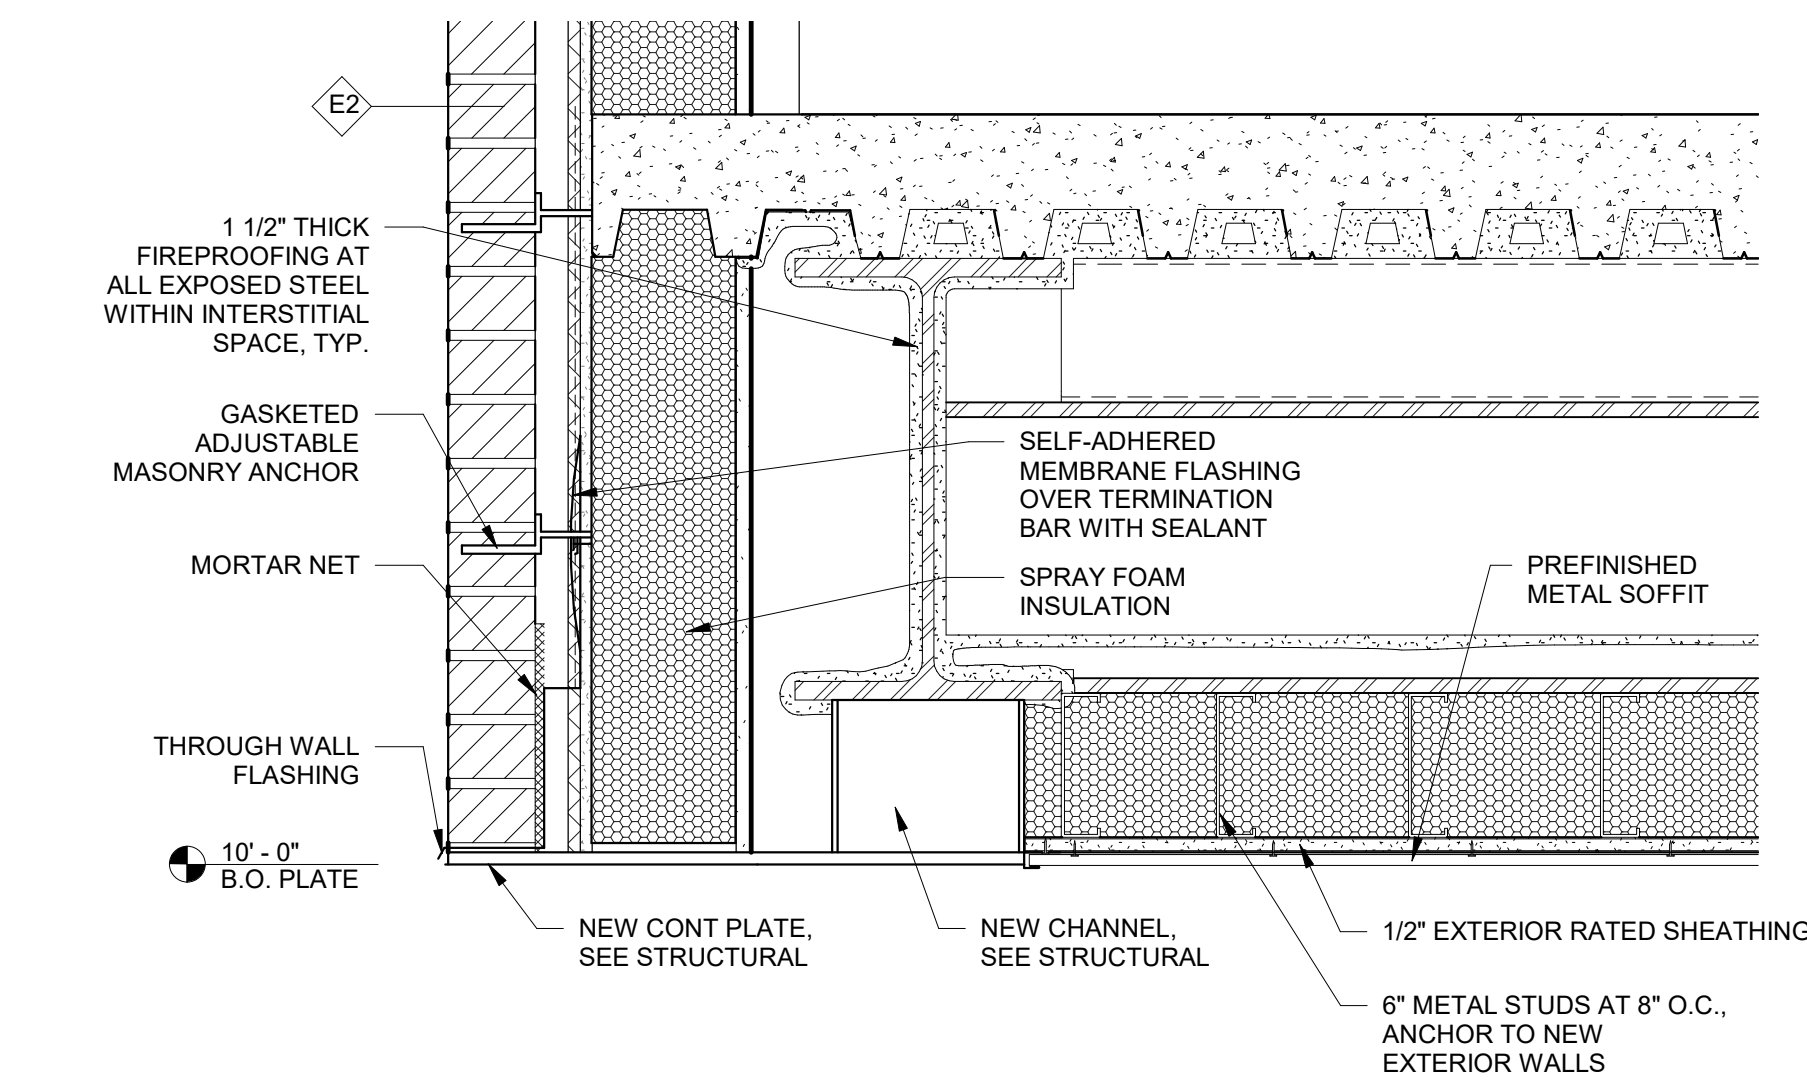
3 WALL BASE FLASHING DETAIL
1 1/2" = 1'-0"



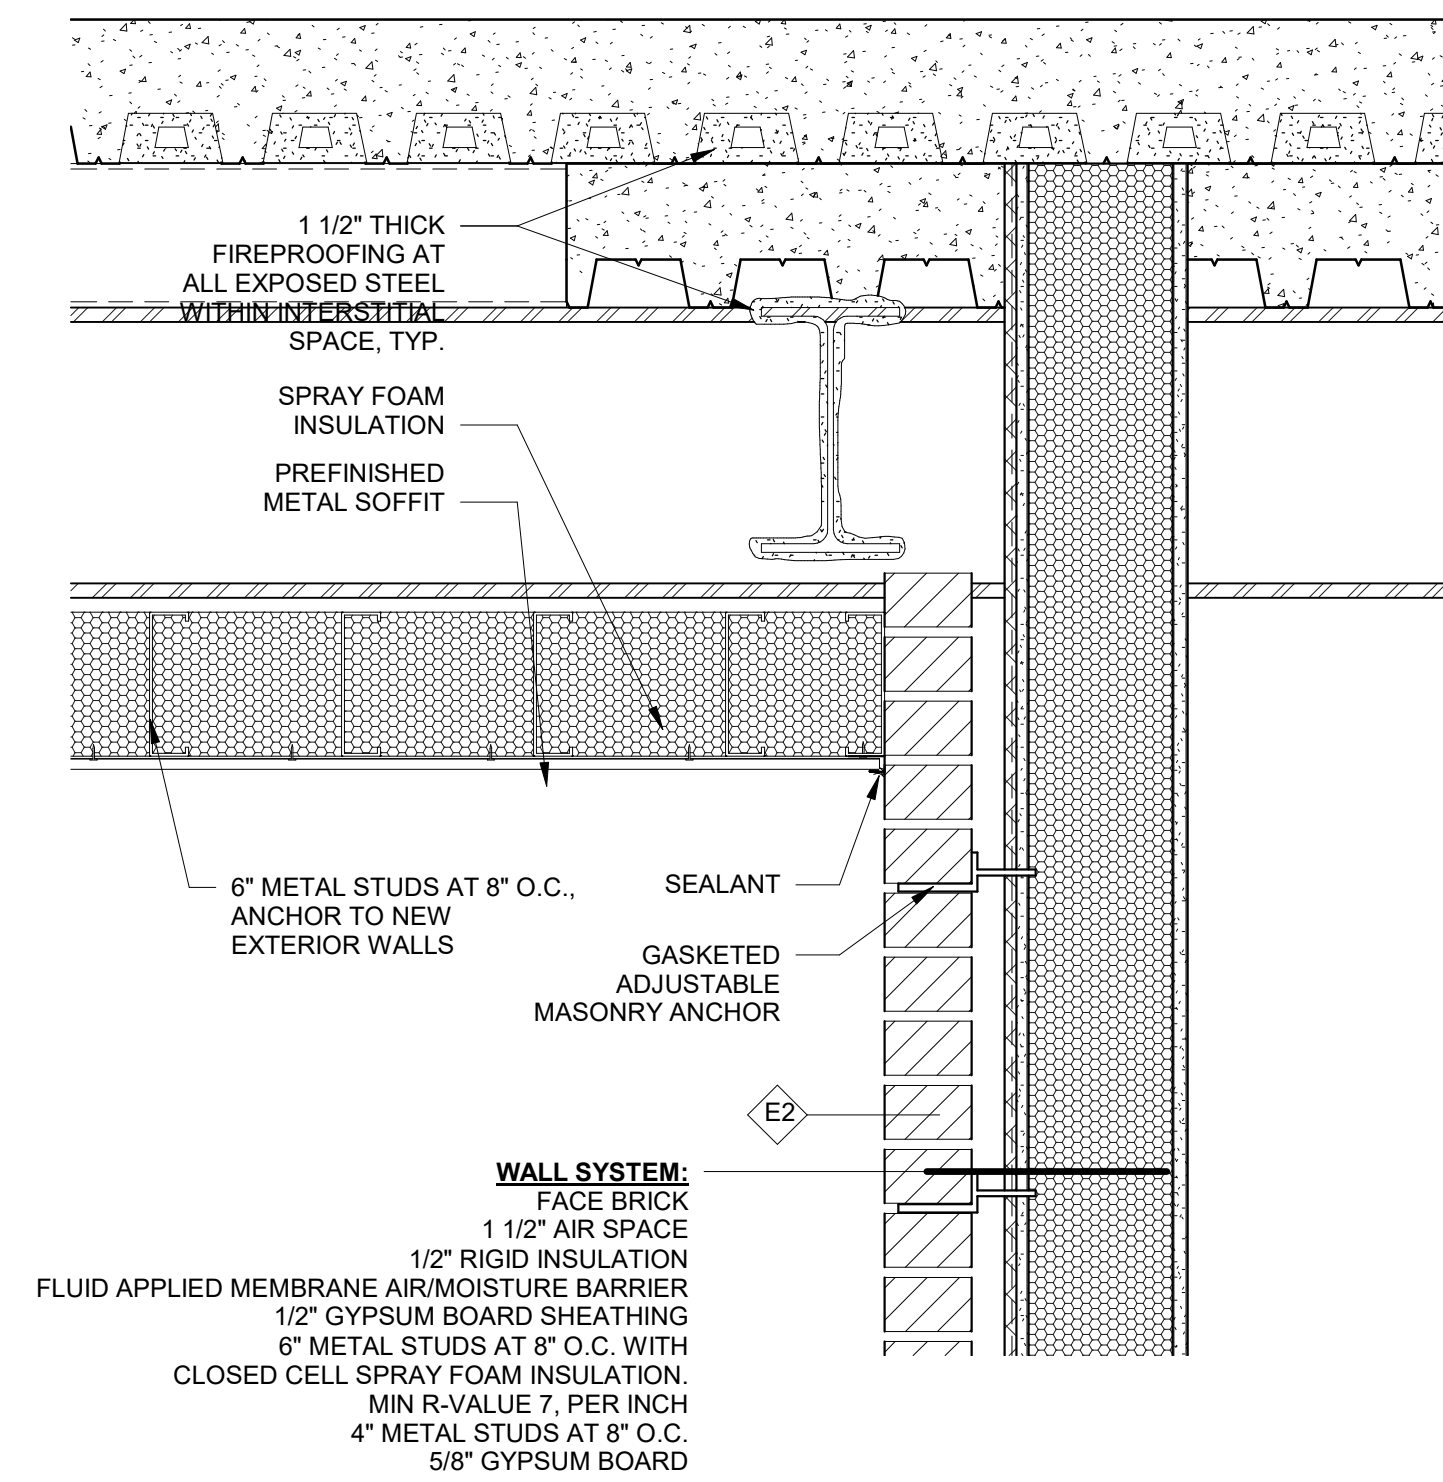
4 EXTERIOR DETAIL AT SOFFIT
1 1/2" = 1'-0"



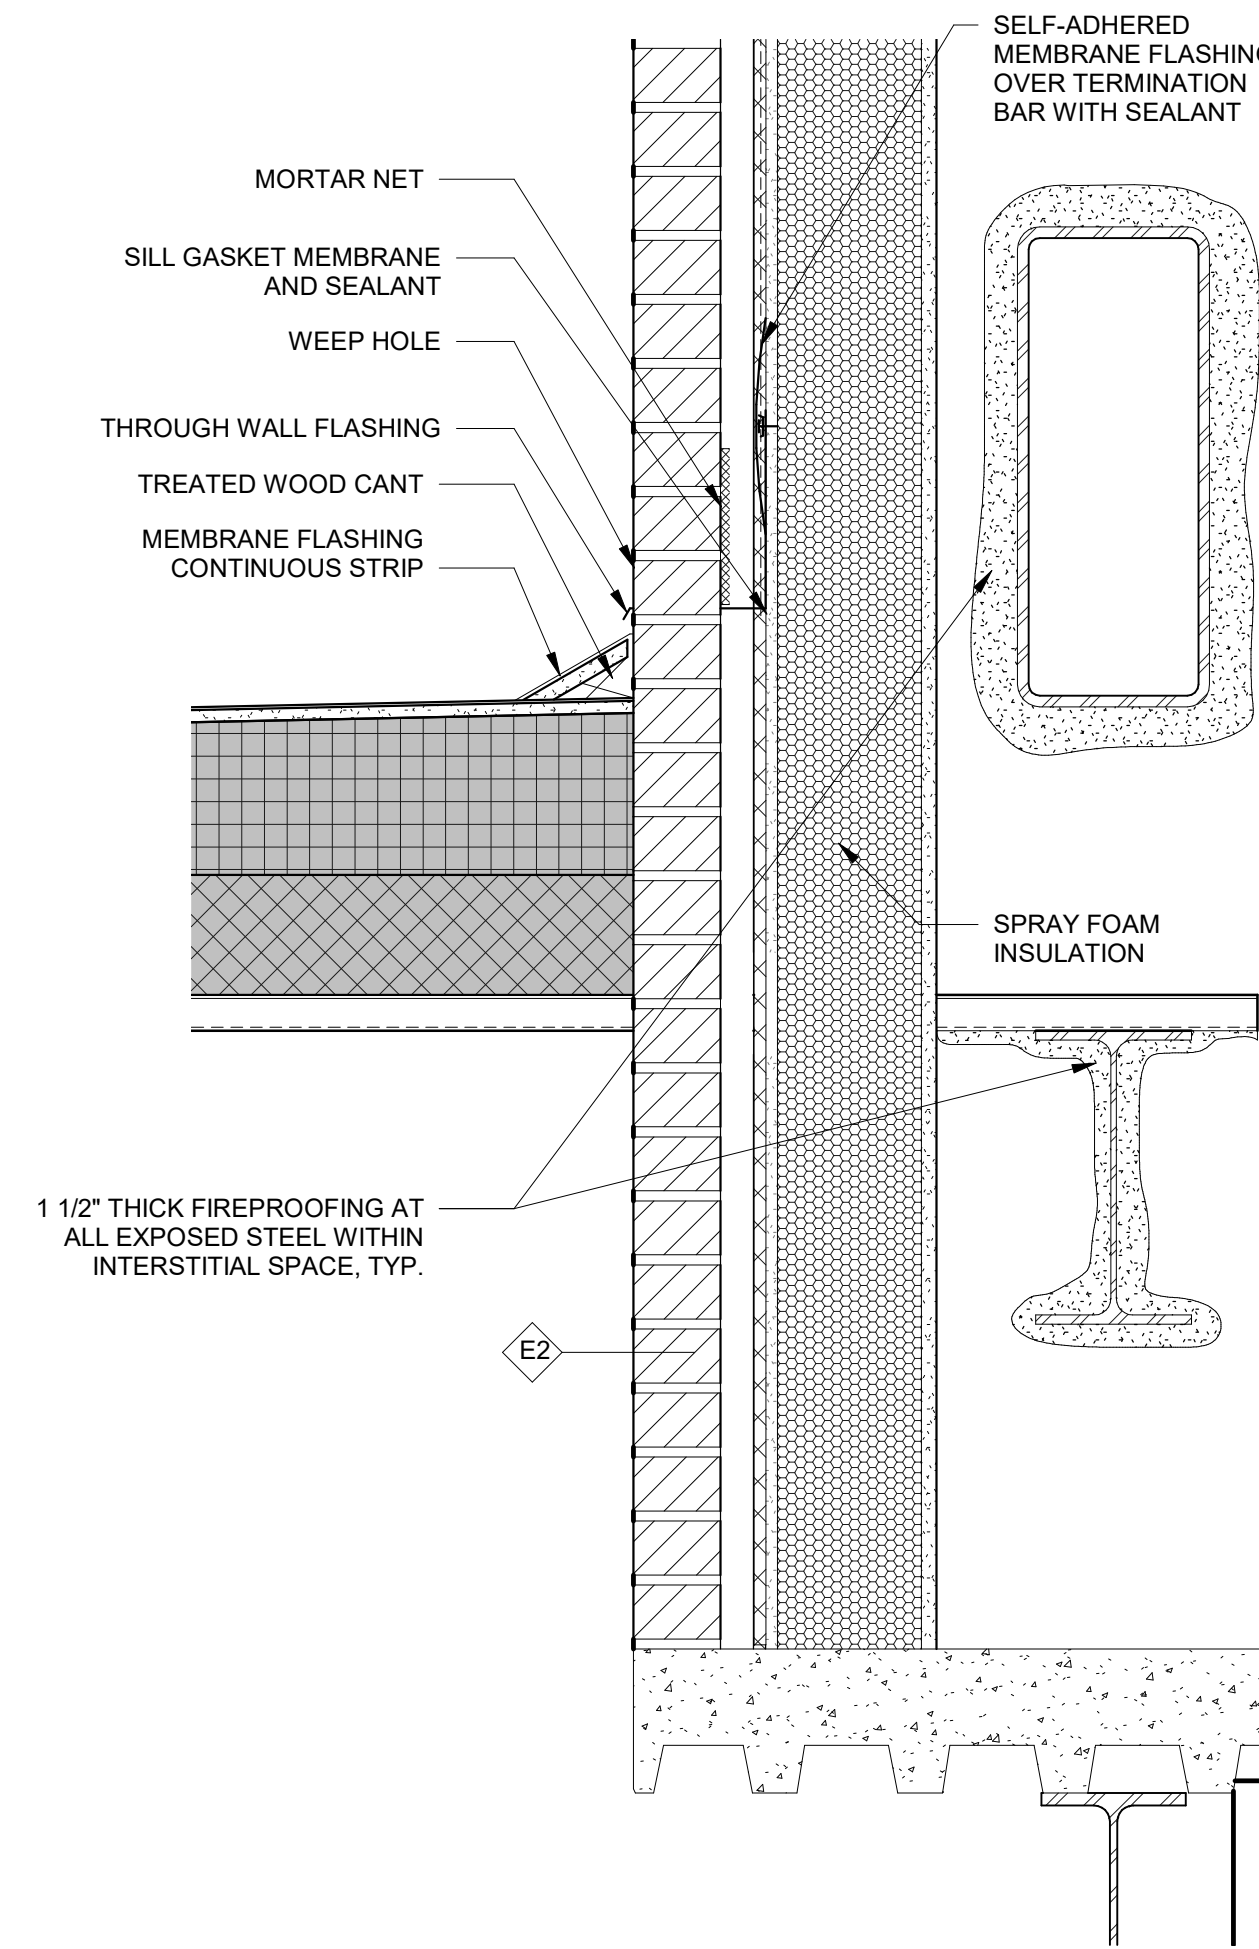
5 EXTERIOR DETAIL AT SOFFIT
1 1/2" = 1'-0"



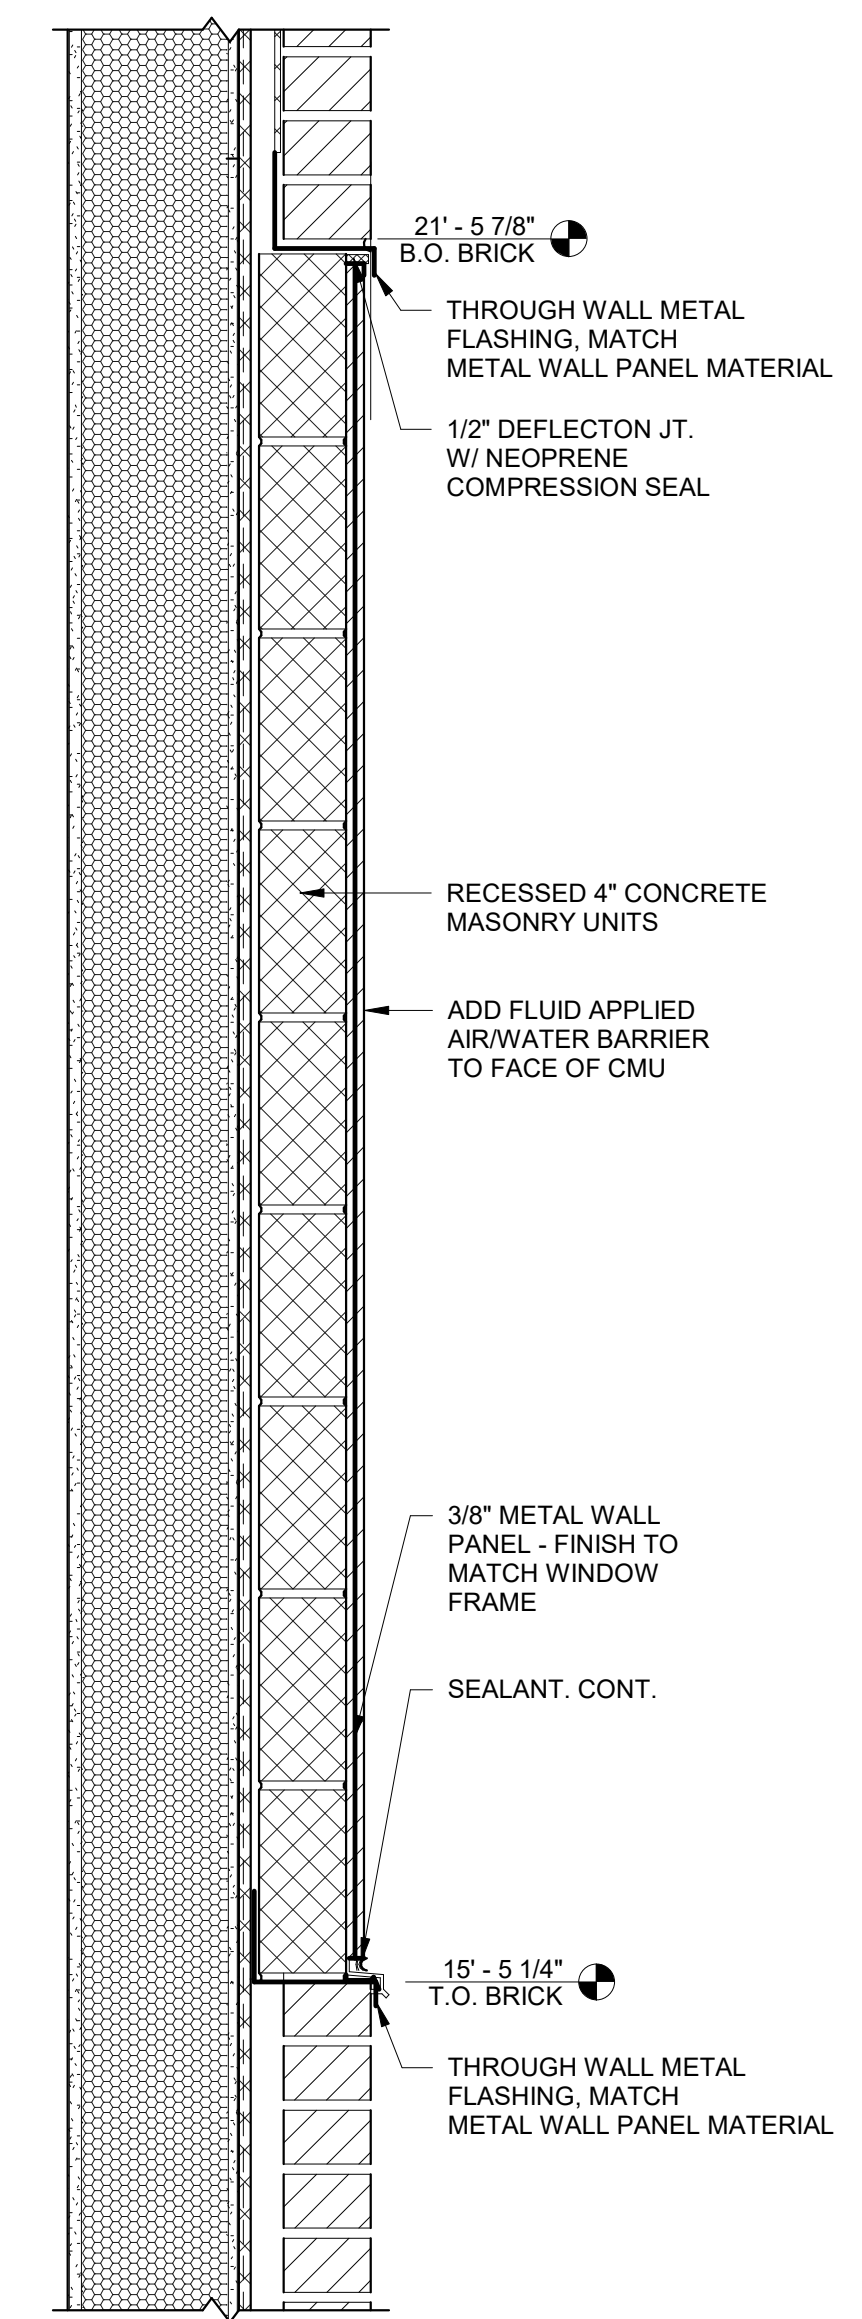6 EXTERIOR WALL BASE DETAIL
1 1/2" = 1'-0"



7 ALUM. PANEL DETAIL
1 1/2" = 1'-0"

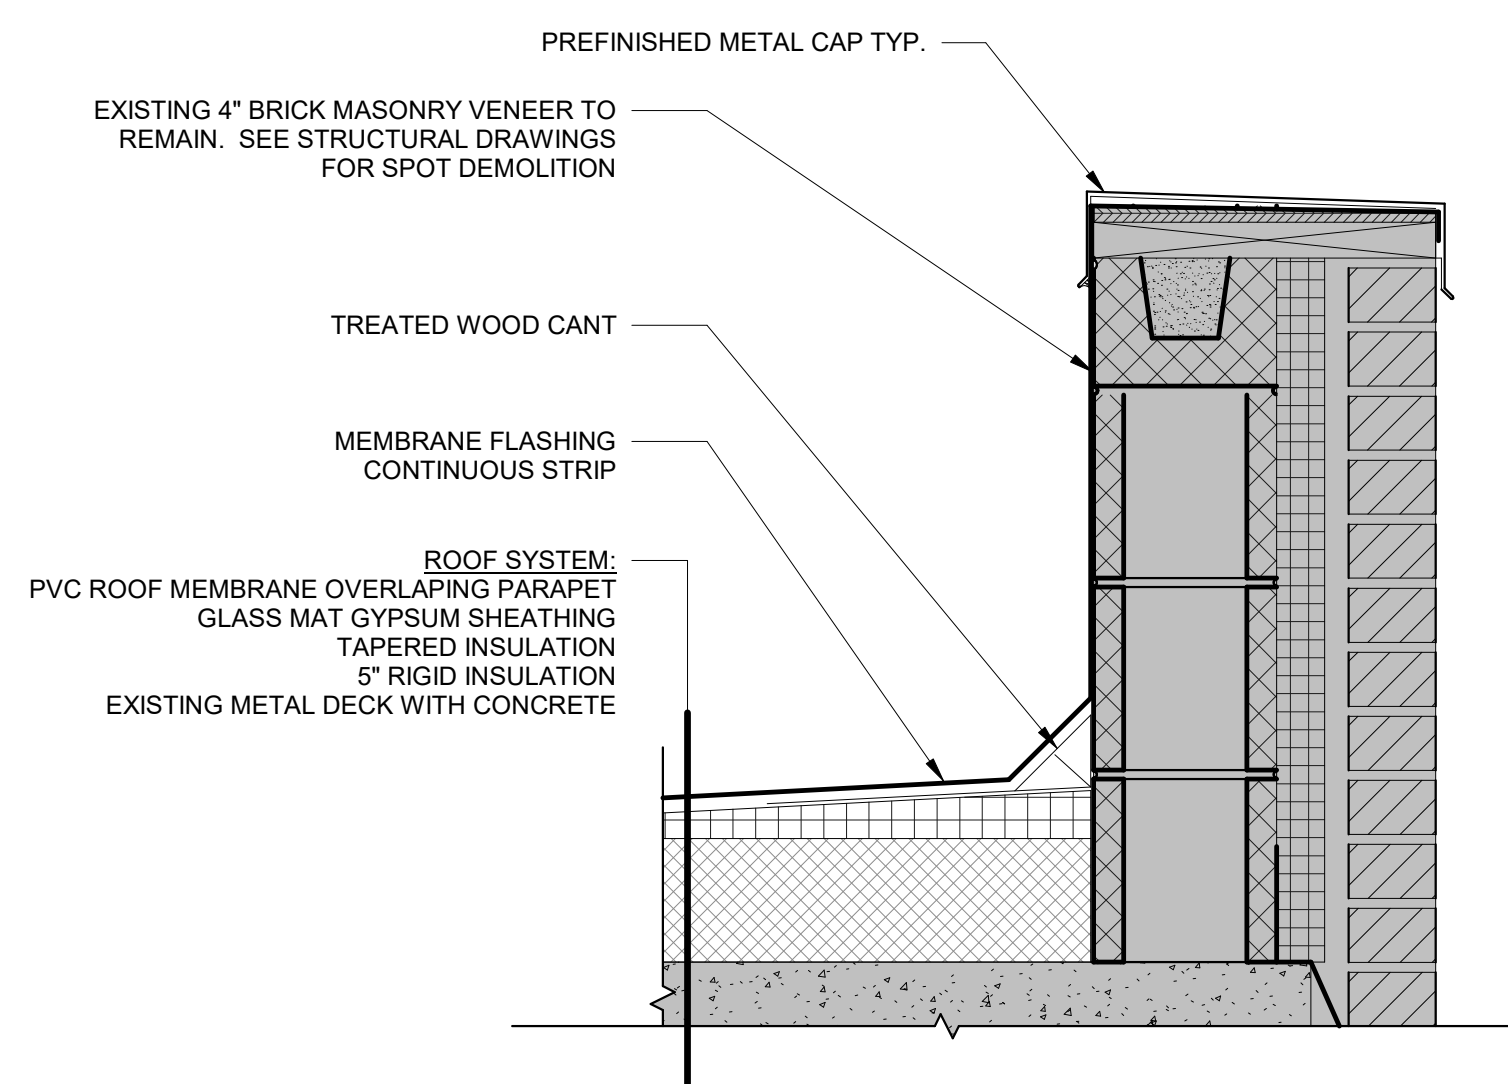

8 PARAPET DETAIL
1 1/2" = 1'-0"

CONSTRUCTION DOCUMENTS

CONSULTANTS:  TERRASITE DESIGN 1635 DEADWOOD AVENUE RAPID CITY, SOUTH DAKOTA 57702 PH: (605) 791-1736  ALBERTSON ENGINEERING, INC. 315 NORTH MAIN AVENUE, SUITE 200 SIOUX FALLS, SOUTH DAKOTA 57104 PH: (605) 274-0880  FARRIS ENGINEERING 12700 WEST DODGE ROAD OMAHA, NEBRASKA 68154 PH: (402) 330-5900		ARCHITECT  FOURFRONT DESIGN, INC. 517 7TH STREET RAPID CITY, SOUTH DAKOTA 57701 PH: (605) 342-9470 FAX: (605) 342-2377 WWW.FOURFRONTDESIGN.COM		Drawing Title SECTION DETAILS Approved: Project Director Omaha VA Medical Center		Project Title Design/Construct Sterile Processing Service- Omaha VA Medical Center Location 4101 Woolworth Ave #4199 Omaha, Ne 68105 Date 11/23/2020		Project Number 16.2330.A08 Building Number 25 Drawing Number A-401 Dwg. 58 of 193		Office of Construction and Facilities Management  Department of Veterans Affairs	
COMPLIANCY REVIEW INCLUDED Revisions:		2/23/2024 Date									



5/18/2023 14:37 PM

one eighth inch = one foot
one quarter inch = one foot
three eighths inch = one foot
one half inch = one foot
three quarters inch = one foot
one foot one inch = one foot
one and one half inches = one foot
one and one half inches = one foot
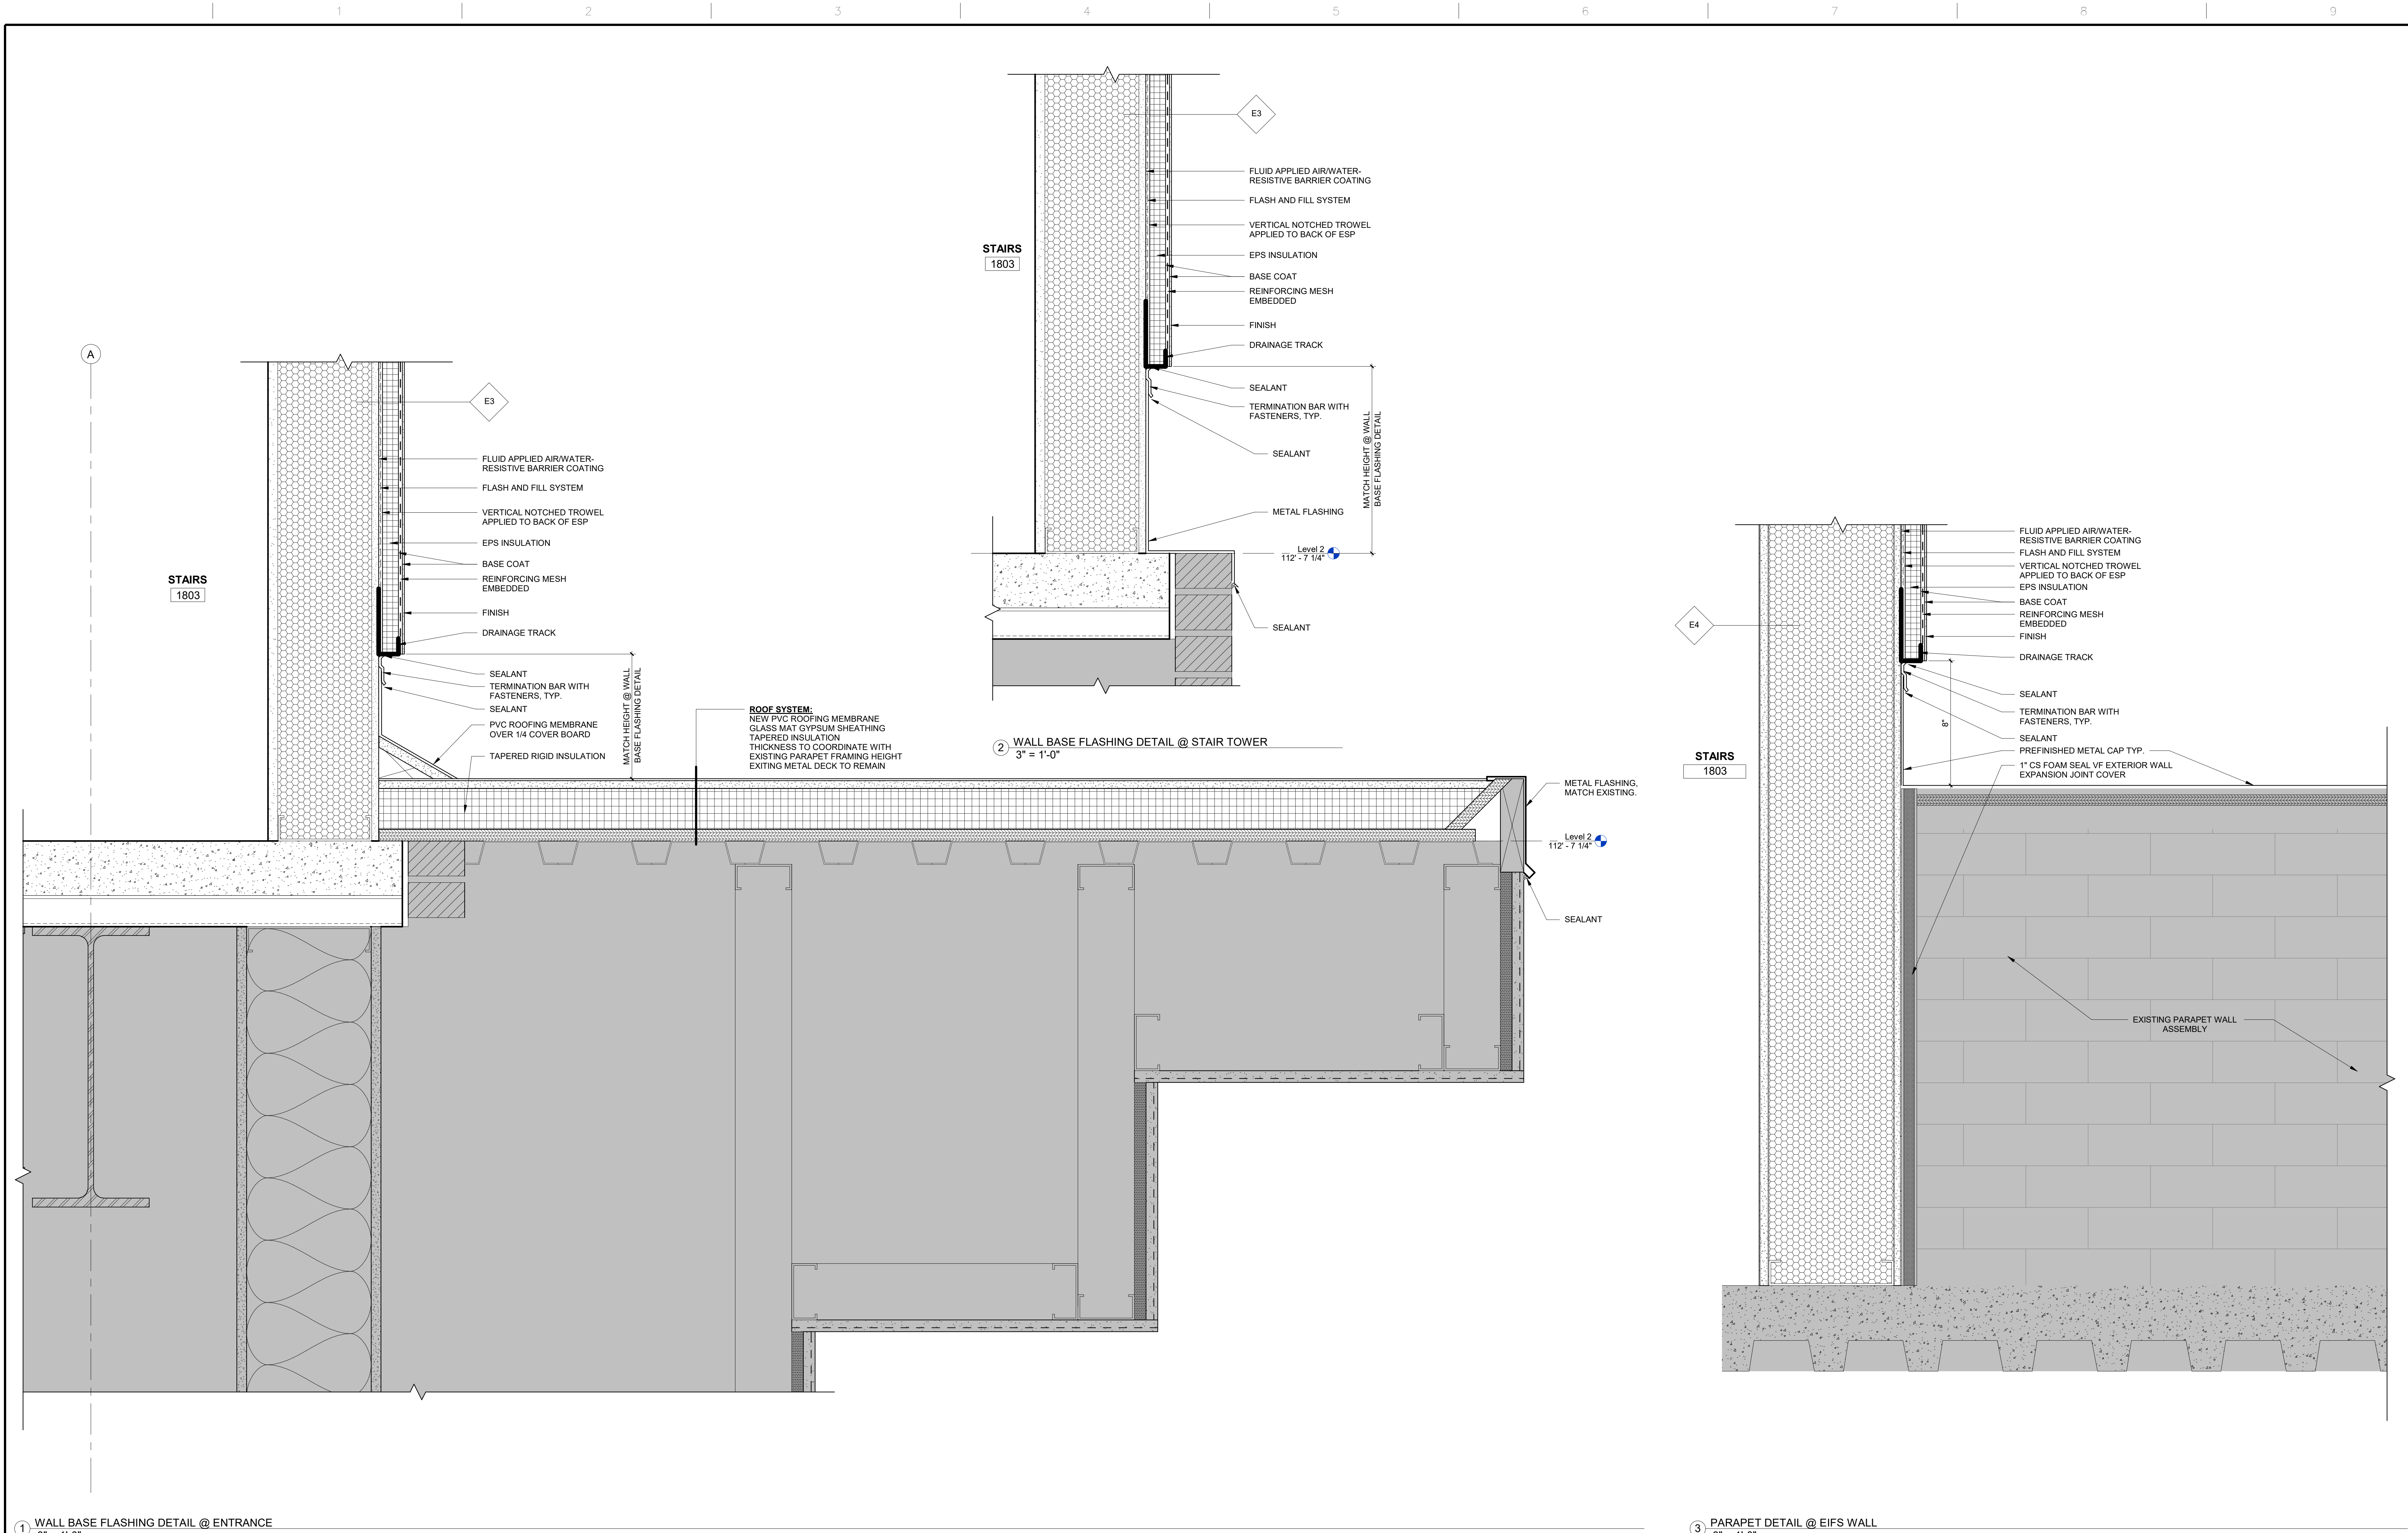
one and one half inches = one foot
one and one half inches = one foot
		CONSULTANTS:				ARCHITECT		Drawing Title		Project Title		Project Number		Office of Construction and Facilities Management	
		 TERRASITE DESIGN 1635 DEADWOOD AVENUE RAPID CITY, SOUTH DAKOTA 57702 PH: (605) 791-1736		 Albertson Engineering Inc. ALBERTSON ENGINEERING, INC. 315 NORTH MAIN AVENUE, SUITE 200 SIOUX FALLS, SOUTH DAKOTA 57104 PH: (605) 274-0880		 FARRIS ENGINEERING 12700 WEST DODGE ROAD OMAHA, NEBRASKA 68154 PH: (402) 330-5900		 FOURFRONT DESIGN, INC. FOURFRONT DESIGN, INC. 517 7TH STREET RAPID CITY, SOUTH DAKOTA 57701 PH: (605) 342-9470 FAX: (605) 342-2377 WWW.FOURFRONTDESIGN.COM		Design/Construct Sterile Processing Service- Omaha VA Medical Center		16.2330.A08			
COMPLIANCE REVIEW INCLUDED		2/23/2024						Approved: Project Director		Location 4101 Woolworth Ave #4199 Omaha, Ne 68105		Building Number		25	
Revisions:		Date						Omaha VA Medical Center		Date 11/23/2020		Checked JL			
												A-401.2		Dwg. 60 of 193	

5/18/2023 1:54:30 PM

one eighth inch = one foot
one quarter inch = one foot
three eighths inch = one foot
one half inch = one foot
three quarters inch = one foot
one foot one inch = one foot
one and one half inches = one foot
one and one half inches = one foot
one and one half inches = one foot

A

B

C

D

E

F

A

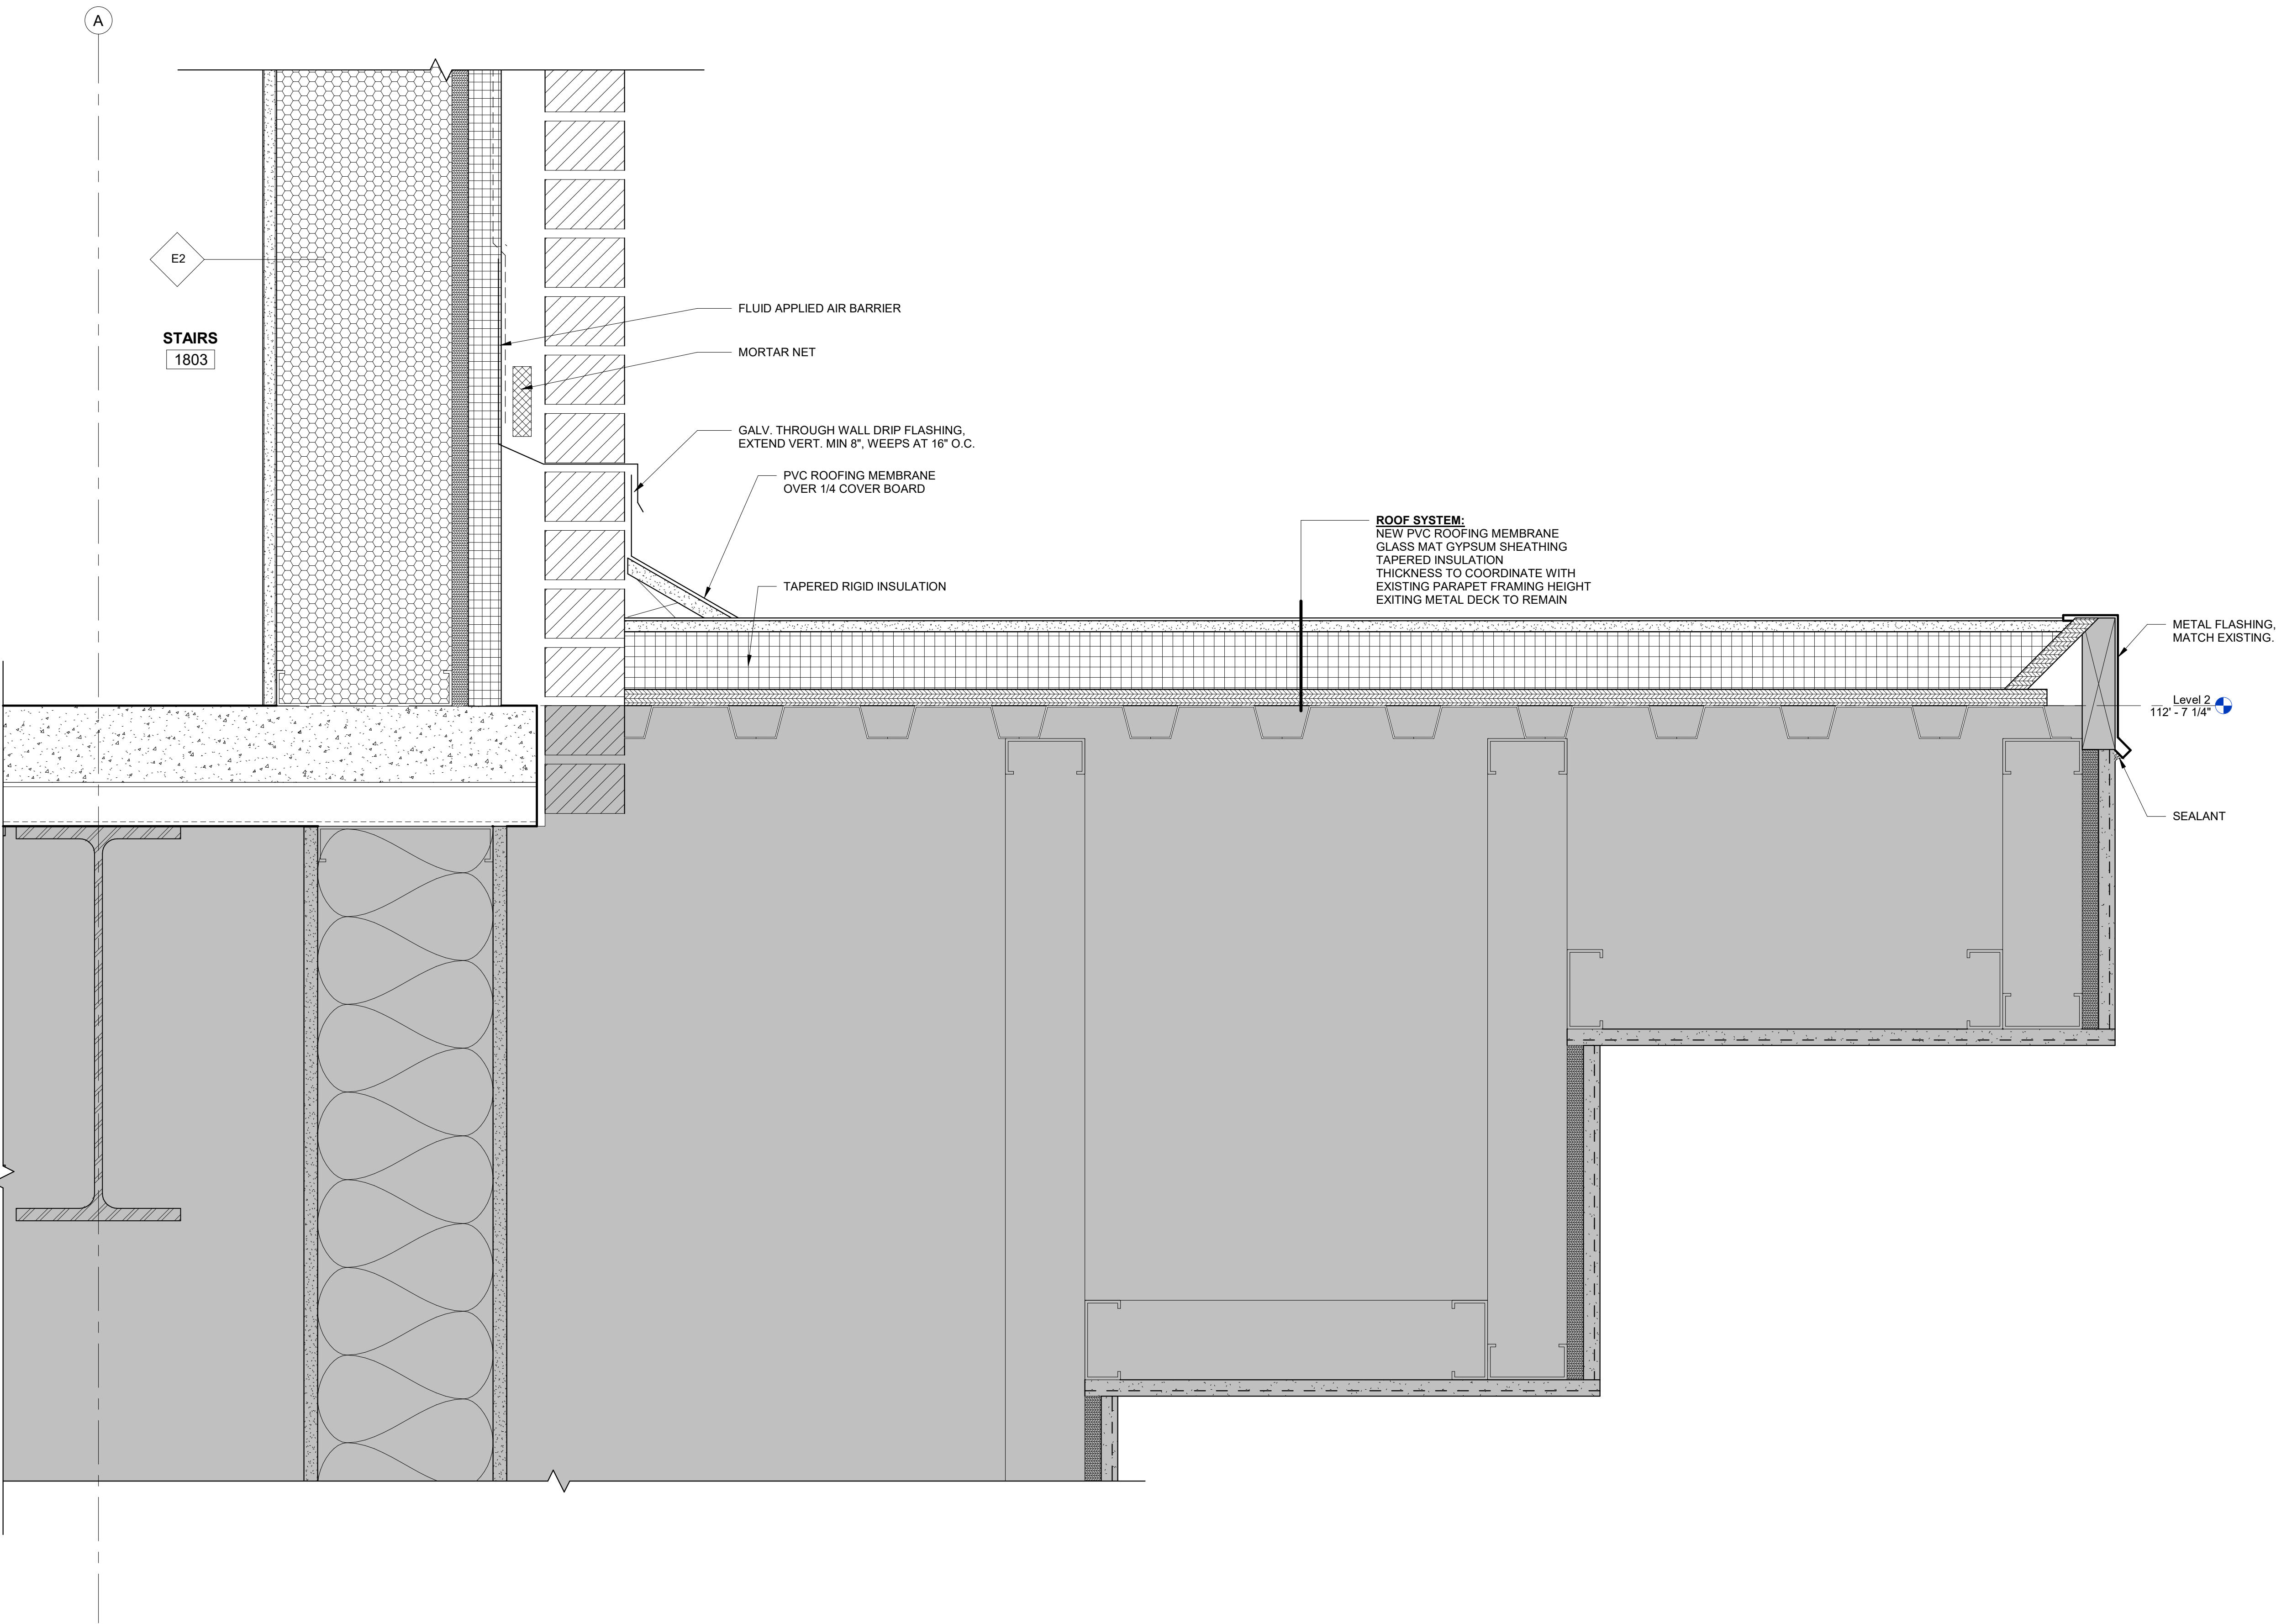
B

C


D

E

F





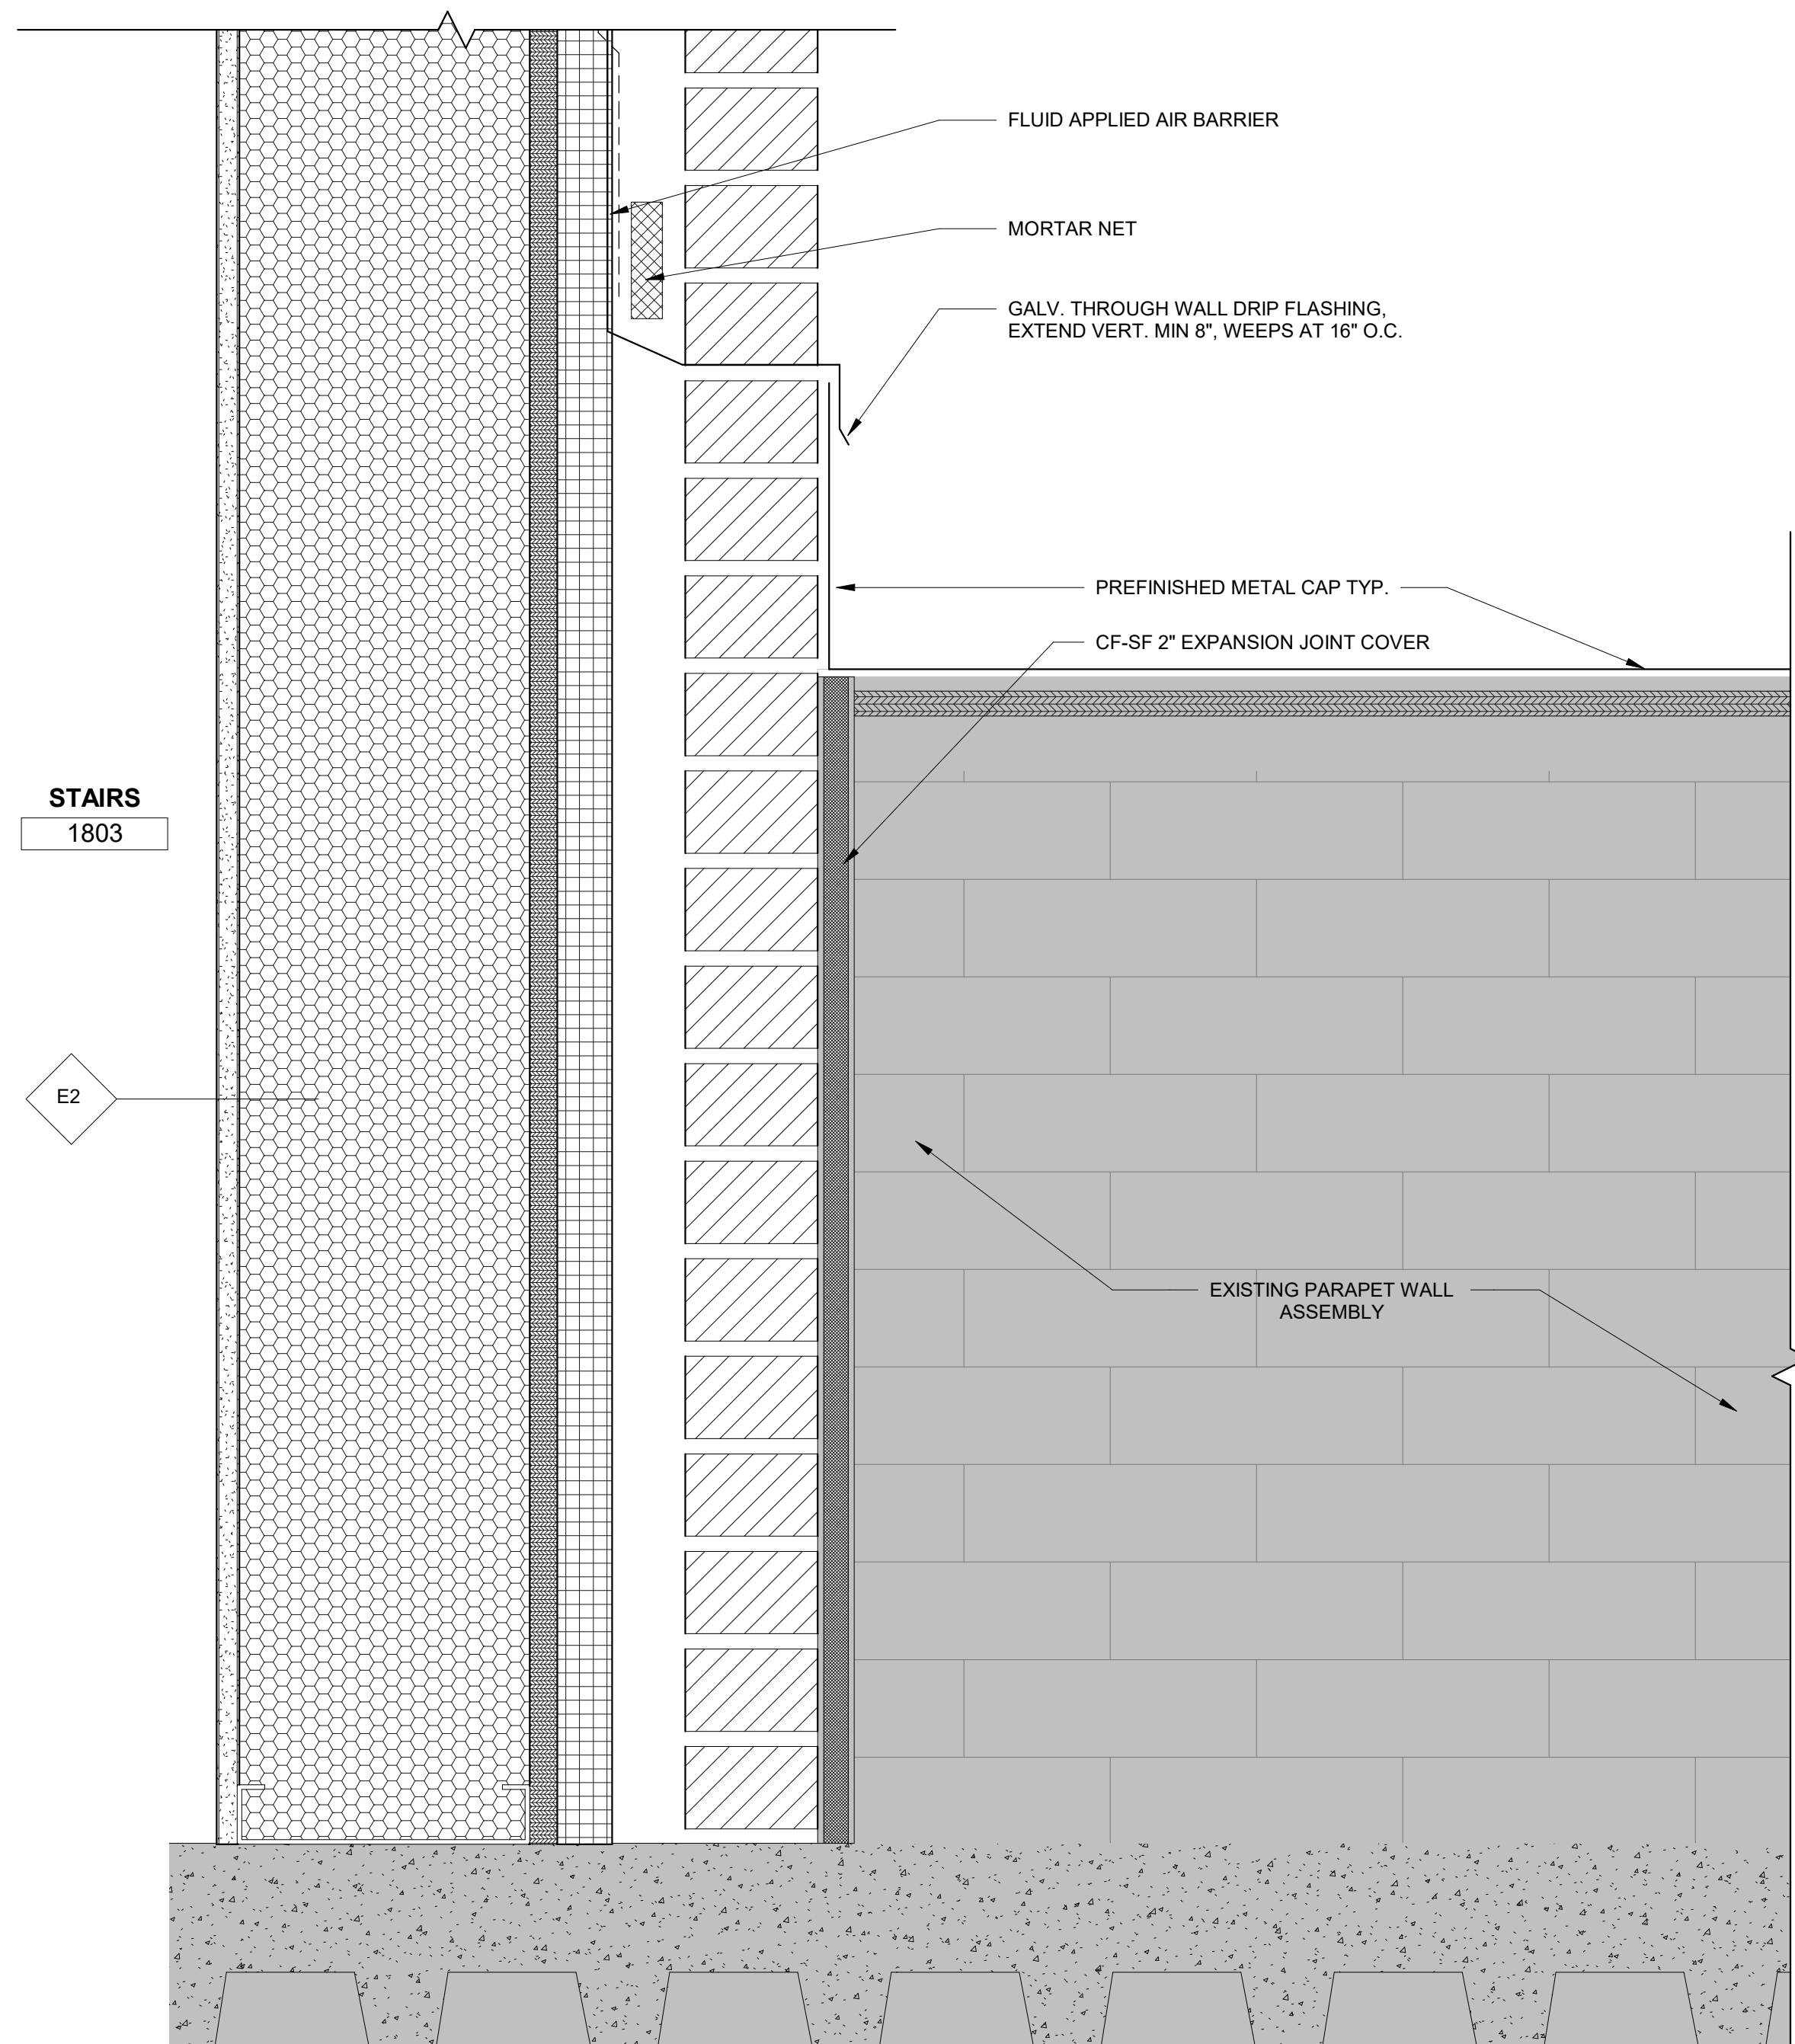1 WALL BASE FLASHING DETAIL @ BRICK VENEER ENTRANCE
3" = 1'-0"





2 PARAPET DETAIL @ BRICK VENEER WALL 2
3" = 1'-0"

  CONSTRUCTION DOCUMENTS


		CONSULTANTS:				ARCHITECT		Drawing Title		Project Title		Project Number		Office of Construction and Facilities Management	
		 TERRASITE DESIGN 1635 DEADWOOD AVENUE RAPID CITY, SOUTH DAKOTA 57702 PH: (605) 791-1736		 Albertson Engineering Inc.		ALBERTSON ENGINEERING, INC. 315 NORTH MAIN AVENUE, SUITE 200 SIOUX FALLS, SOUTH DAKOTA 57104 PH: (605) 274-0880		SECTION DETAILS		Design/Construct Sterile Processing Service- Omaha VA Medical Center		16.2330.A08			
				 FARRIS ENGINEERING 12700 WEST DODGE ROAD OMAHA, NEBRASKA 68154 PH: (402) 330-5900		 FOURFRONT DESIGN, INC. 517 7TH STREET RAPID CITY, SOUTH DAKOTA 57701 PH: (605) 342-9470 FAX: (605) 342-2377 WWW.FOURFRONTDESIGN.COM		Approved: Project Director Omaha VA Medical Center		Location 4101 Woolworth Ave #4199 Omaha, Ne 68105		Drawing Number A-402		Department of Veterans Affairs	
COMPLIANCE REVIEW INCLUDED		2/23/2024						Date 11/23/2020		Checked JL		Drawn JGC			
Revisions:		Date													

5/18/2023 2:02:05 PM

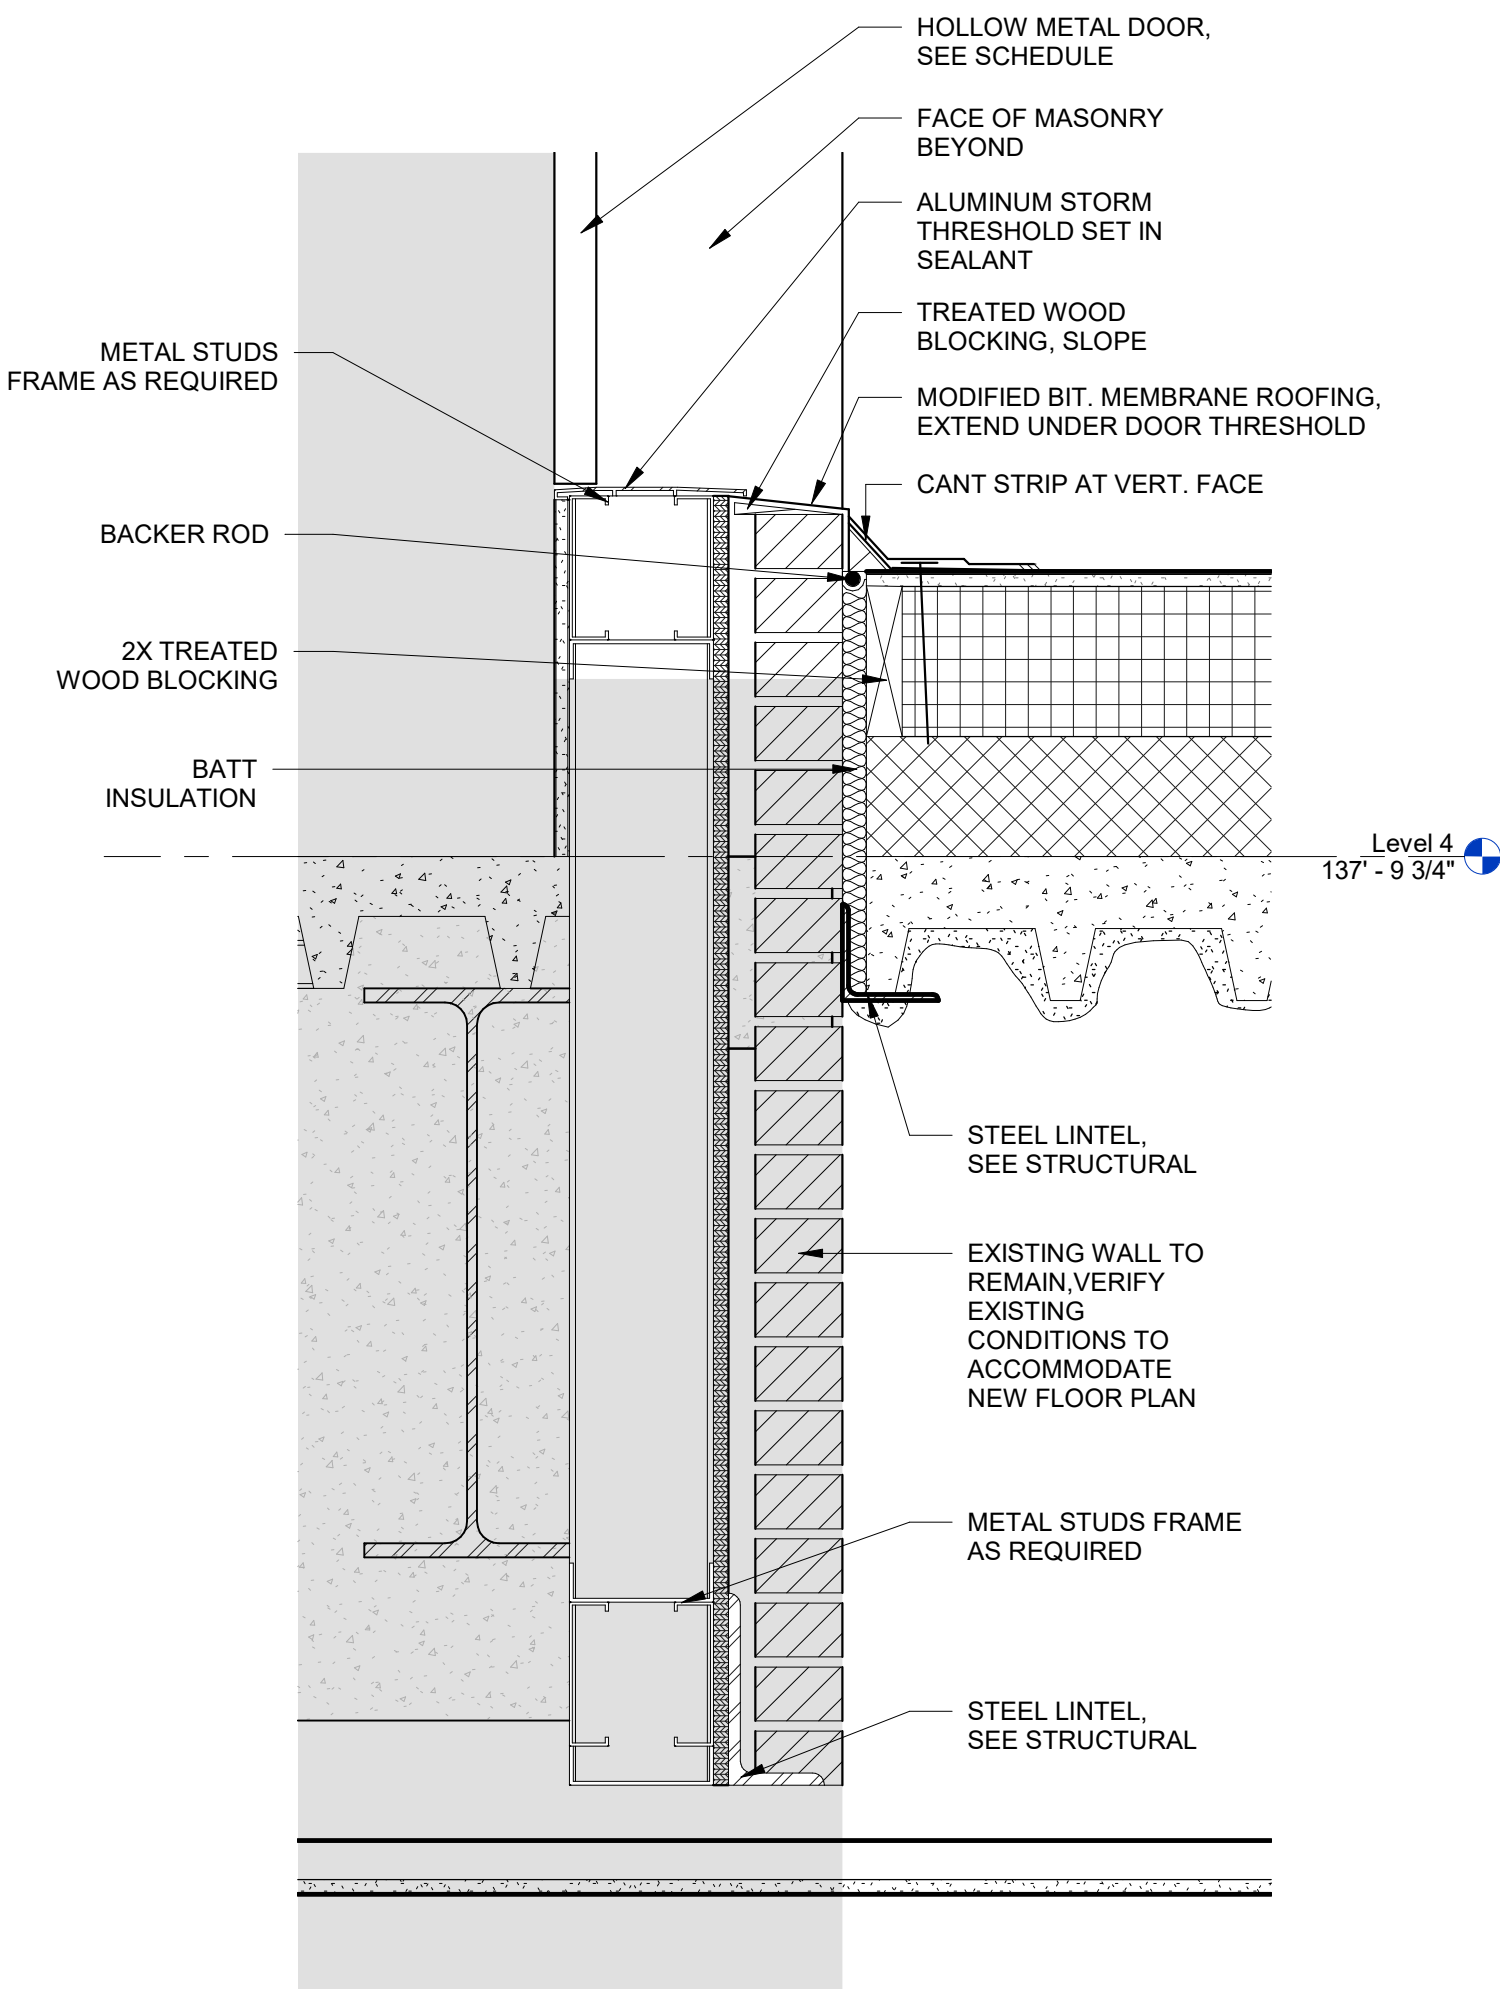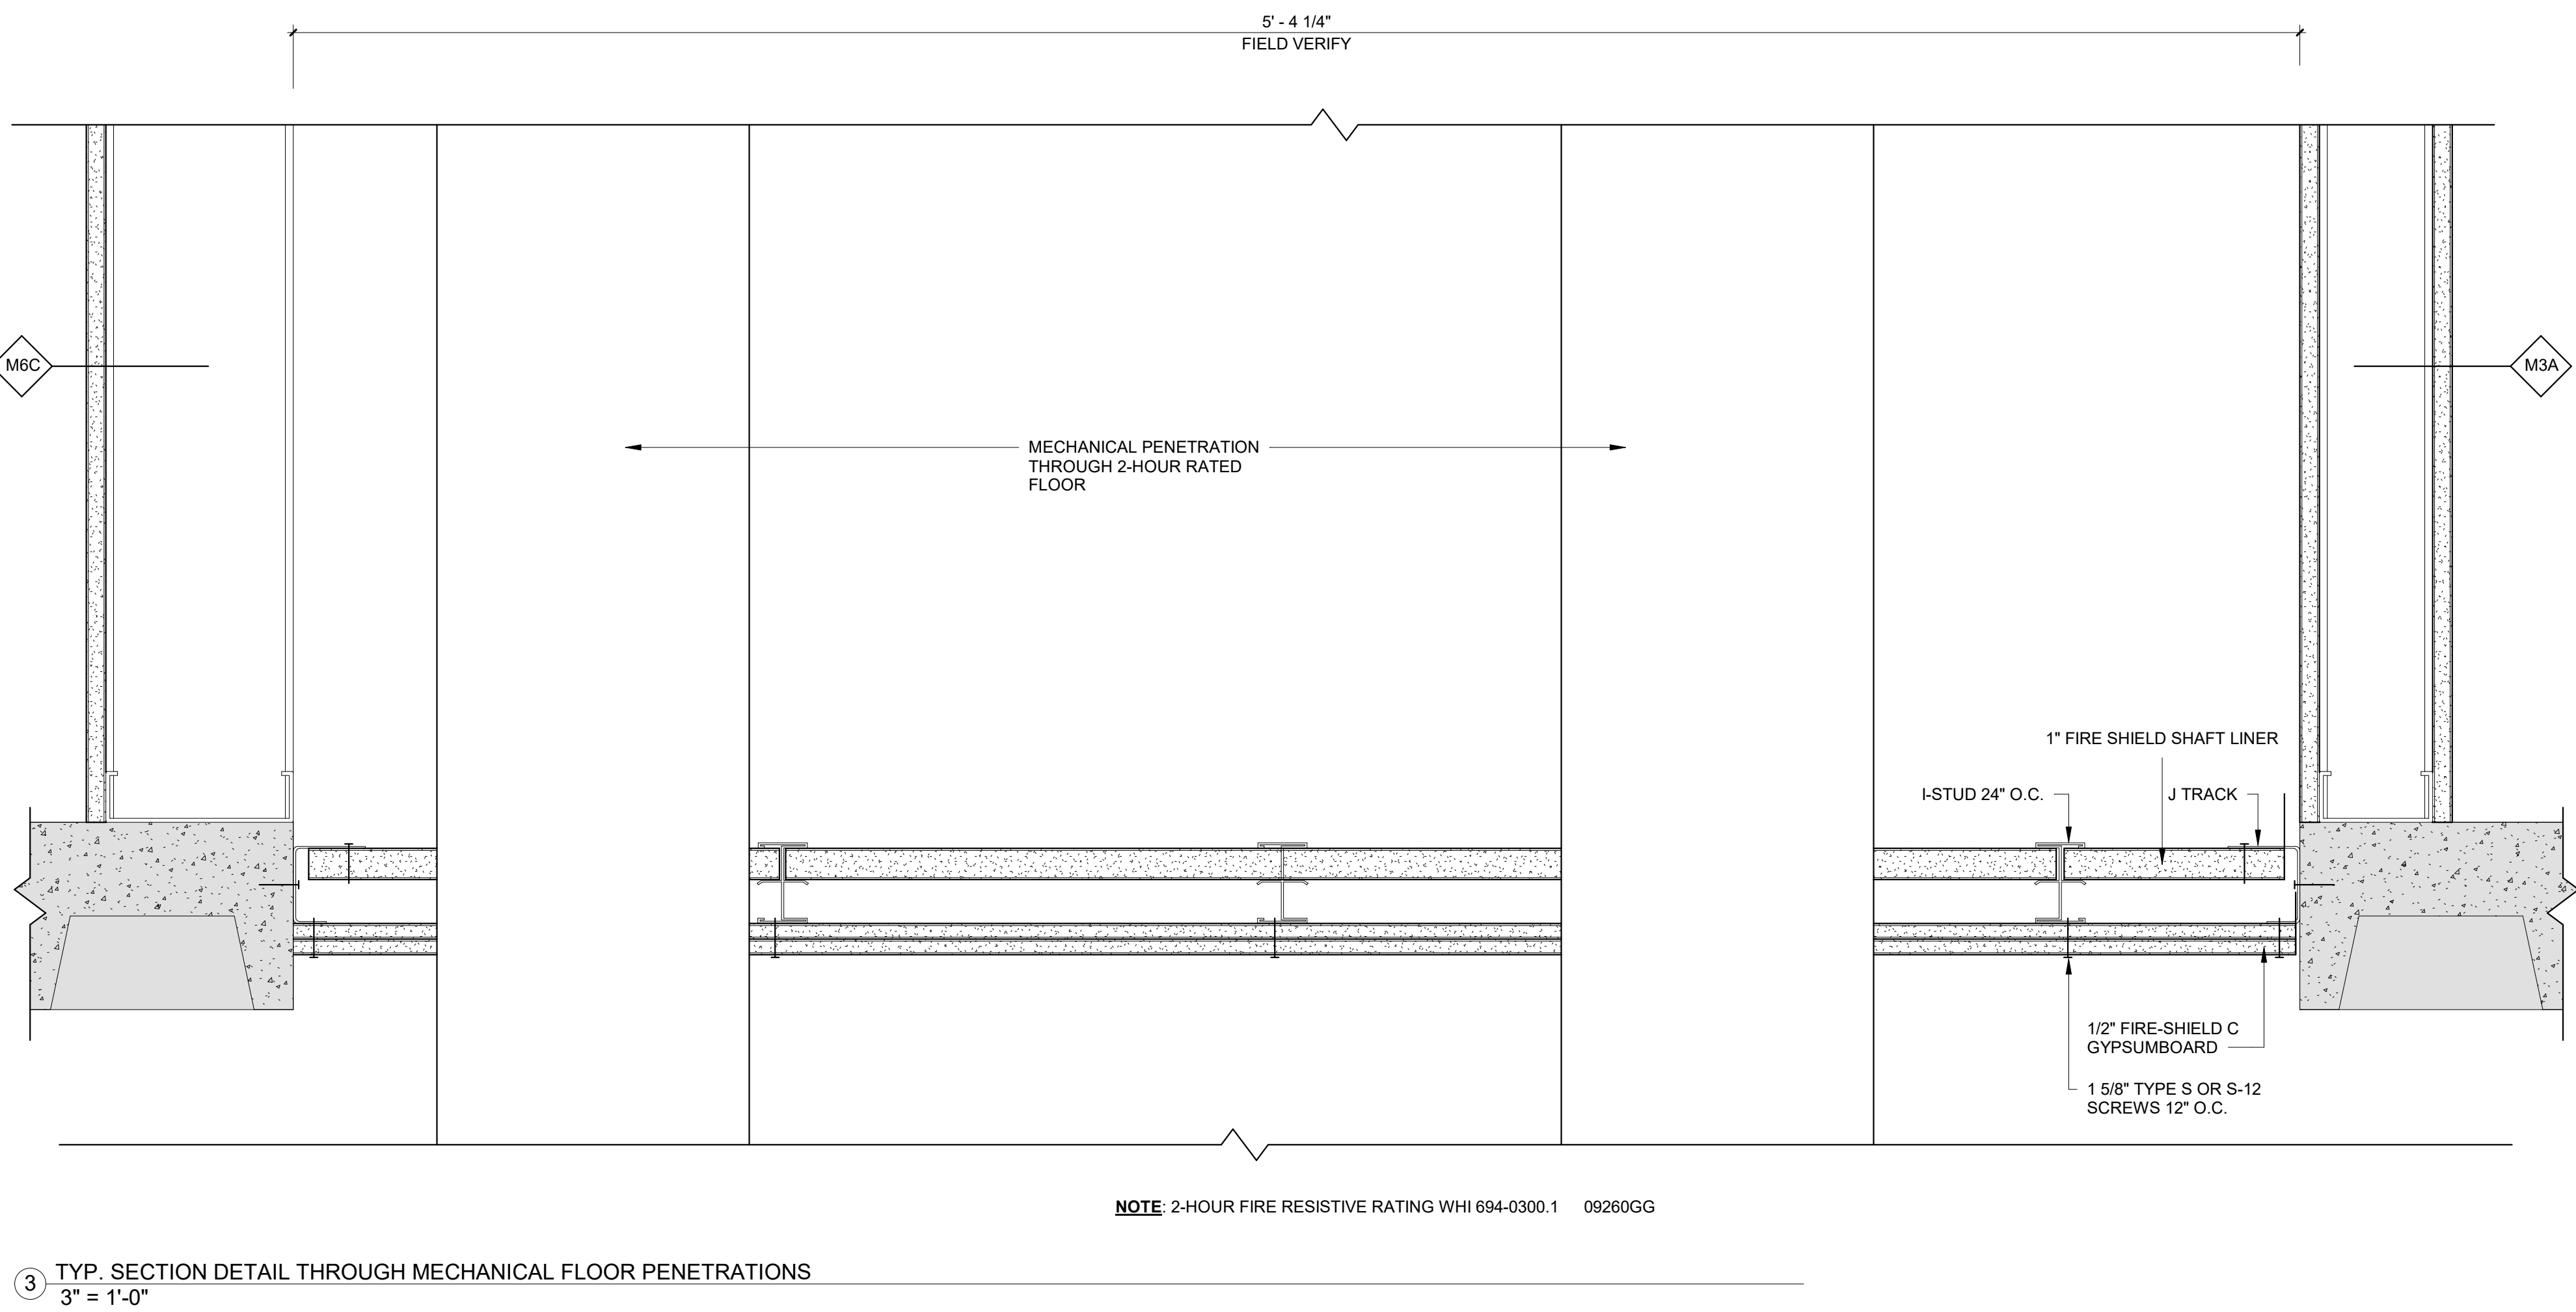one eighth inch = one foot
one quarter inch = one foot
three eighths inch = one foot
one half inch = one foot
one foot one inch = one foot
three quarters inch = one foot
two inches = one foot
one and one half inches = one foot
one and three quarters inches = one foot



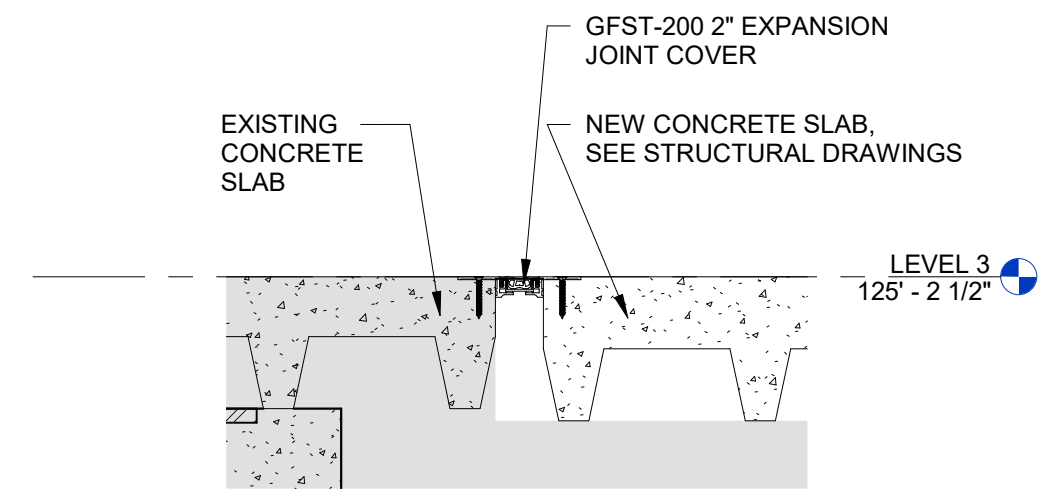1 EXTERIOR DOOR - SILL DETAIL
1 1/2" = 1'-0"



2 FLOOR TO FLOOR EXPANSION DETAIL
1 1/2" = 1'-0"

CONSTRUCTION DOCUMENTS

COMPLIANCE REVIEW INCLUDED	2/23/2024
Revisions:	Date

CONSULTANTS:



TERRASITE DESIGN
1635 DEADWOOD AVENUE
RAPID CITY, SOUTH DAKOTA 57702
PH: (605) 791-1736



Albertson Engineering Inc.



FARRIS ENGINEERING
OMAHA (BRANCH) | SEWELL | COUNCIL BLUFFS
SEWELL, IOWA | PH: (712) 263-1111

ALBERTSON ENGINEERING, INC.
315 NORTH MAIN AVENUE, SUITE 200
SIOUX FALLS, SOUTH DAKOTA 57104
PH: (605) 274-0880

FARRIS ENGINEERING
12700 WEST DODGE ROAD
OMAHA, NEBRASKA 68154
PH: (402) 330-5900



ARCHITECT



FOURFRONT DESIGN, INC.
517 7TH STREET
RAPID CITY, SOUTH DAKOTA
57701
PH: (605) 342-9470
FAX: (605) 342-2377
WWW.FOURFRONTDESIGN.COM

Drawing Title
SECTION DETAILS
Approved: Project Director
Omaha VA Medical Center

Project Title
Design/Construct Sterile Processing Service- Omaha VA Medical Center
Location
4101 Woolworth Ave #4199 Omaha, Ne 68105
Date
11/23/2020

Project Number
16.2330.A08
Building Number
25
Drawing Number
A-403
Dwg. 62 of 193

Office of Construction and Facilities Management
Department of Veterans Affairs

7/27/2022 3:05:01 PM

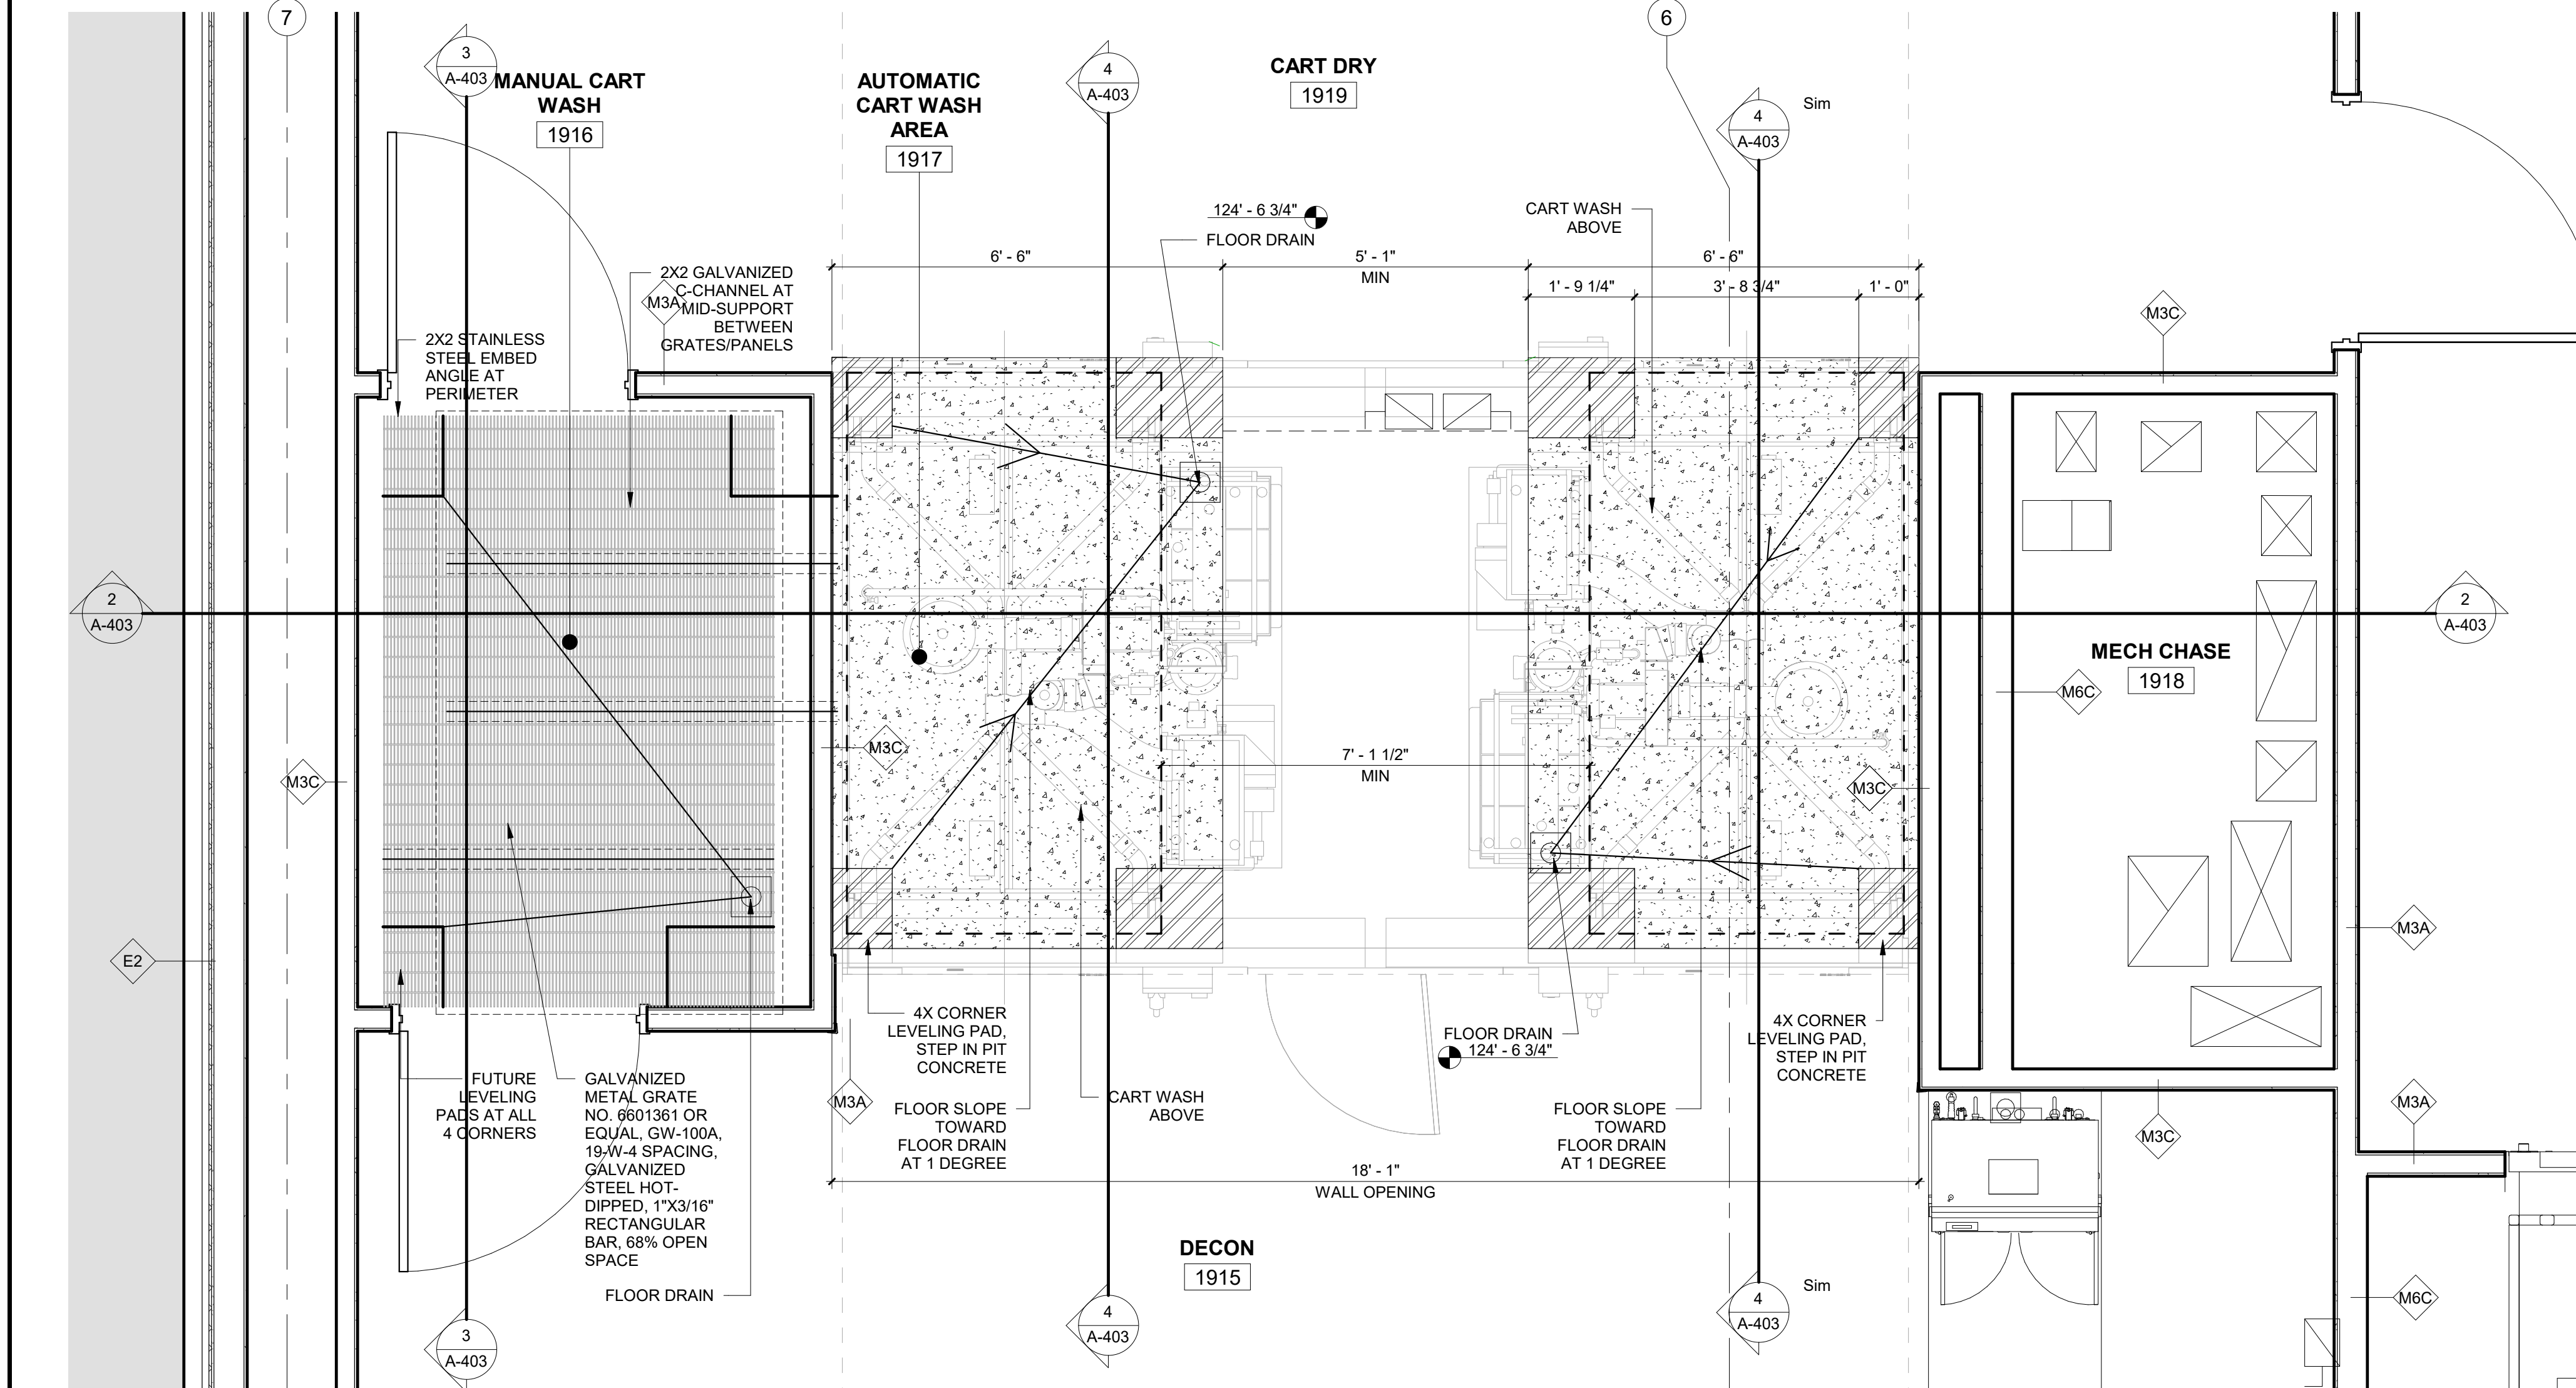
one and one half inches = one foot

three quarters inch = one foot one inch = one foot


three eighths inch = one foot one half inch = one foot

one quarter inch = one foot


one eighth inch = one foot



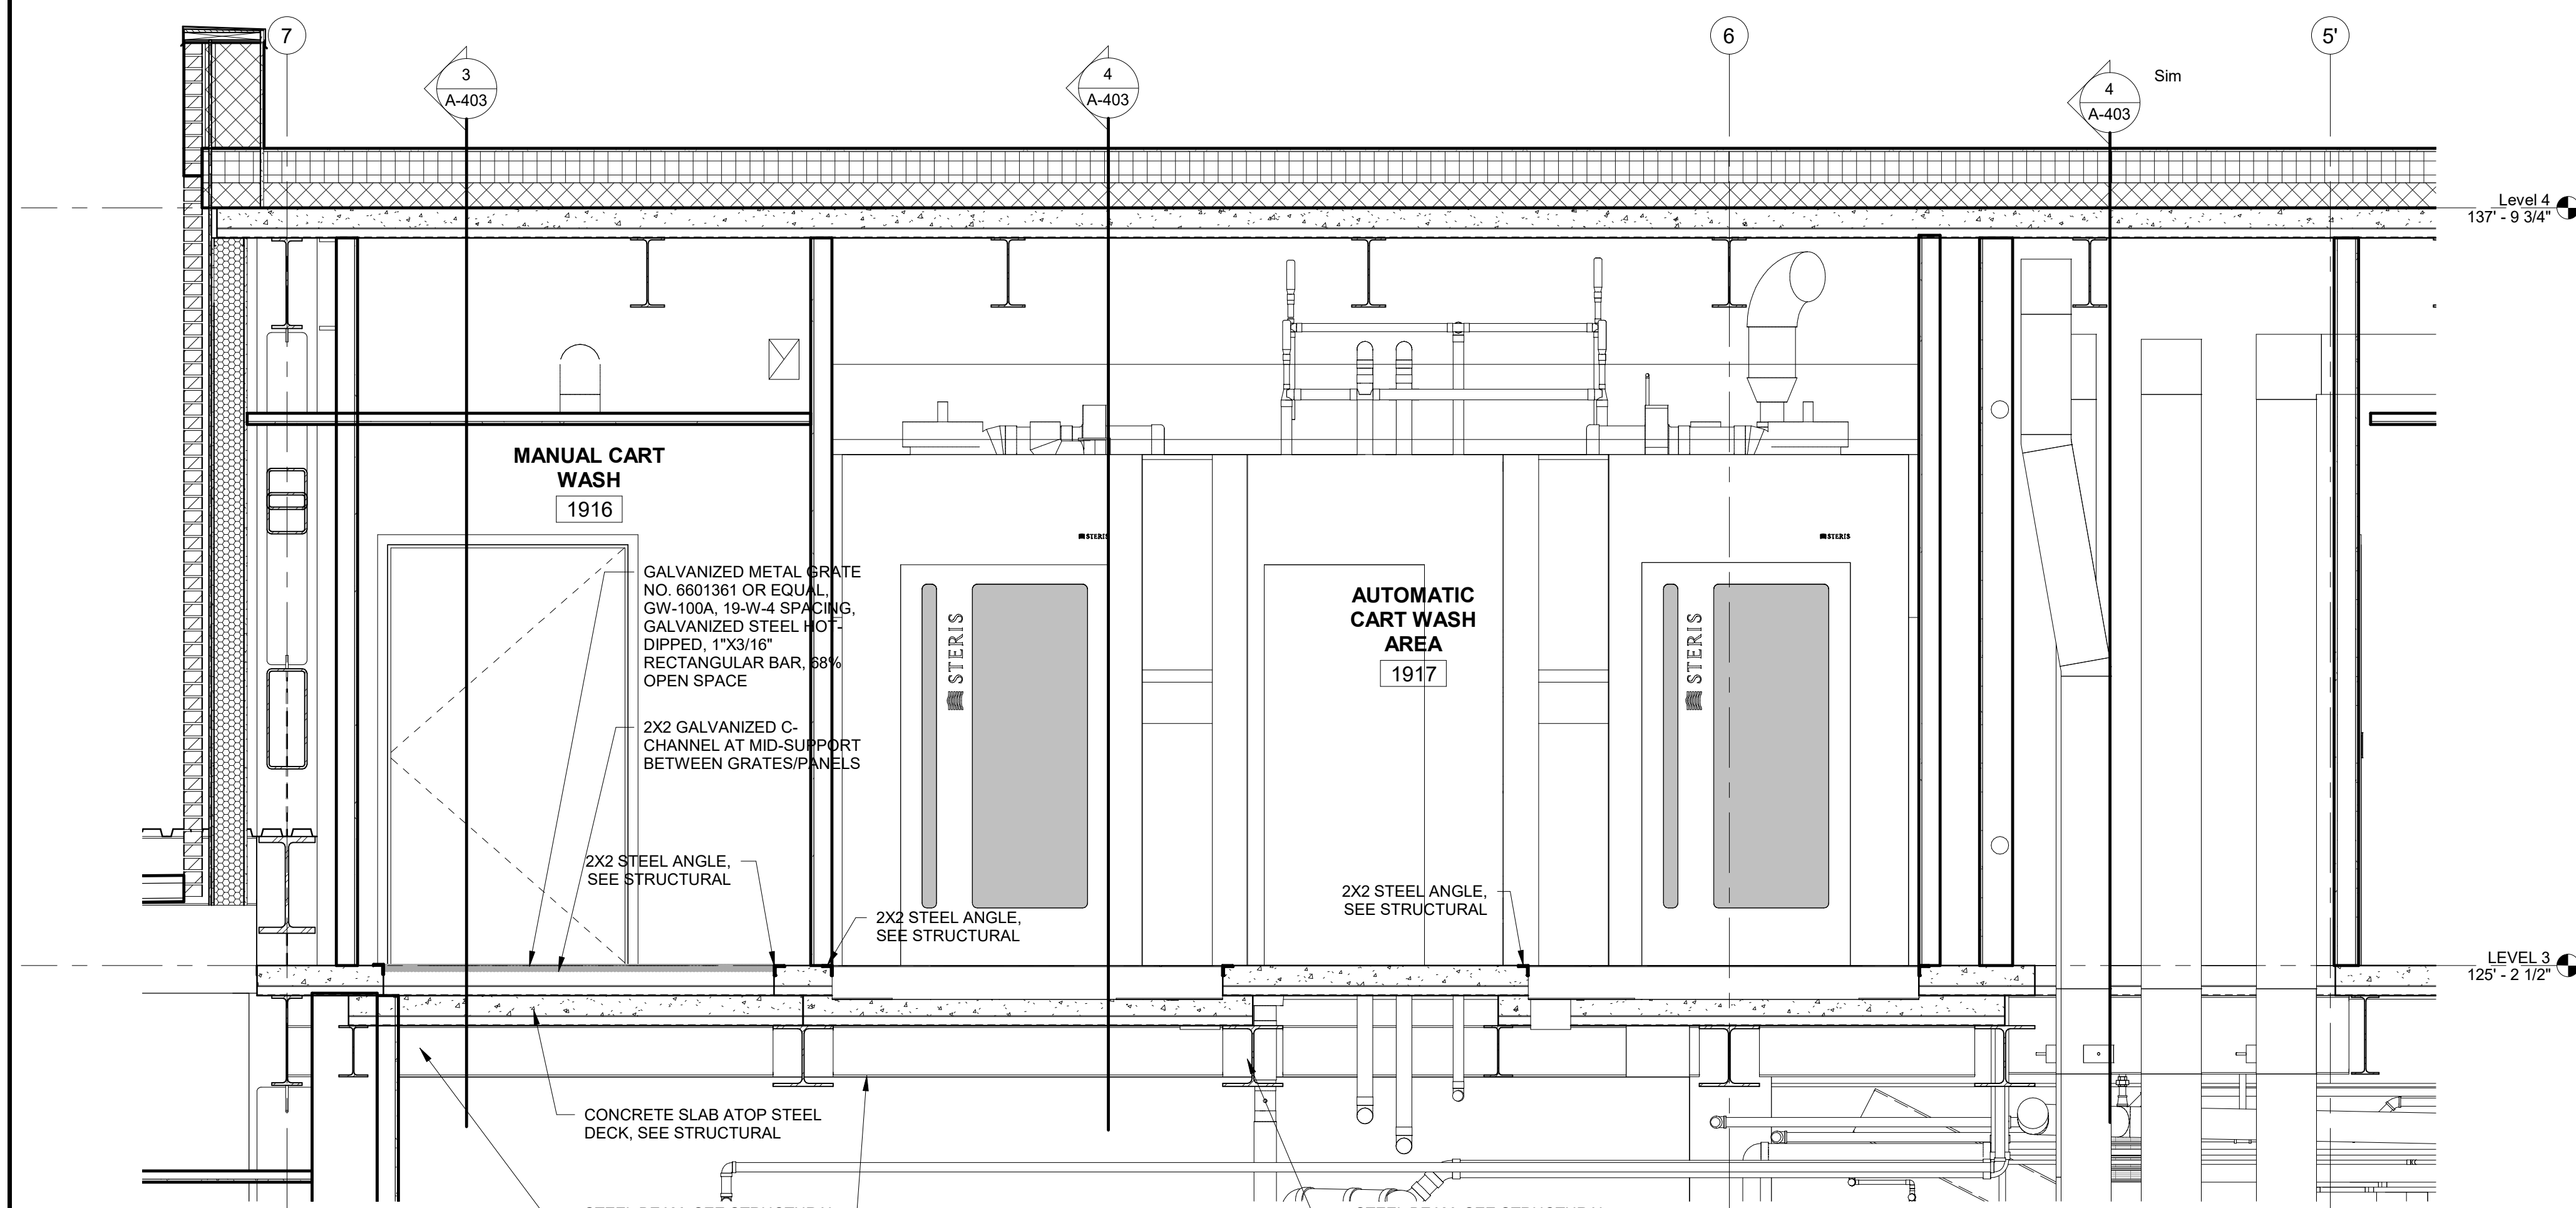
1 ENLARGED PLAN - CART WASH
1/2" = 1'-0"




2 CART WASH SECTION
1/2" = 1'-0"

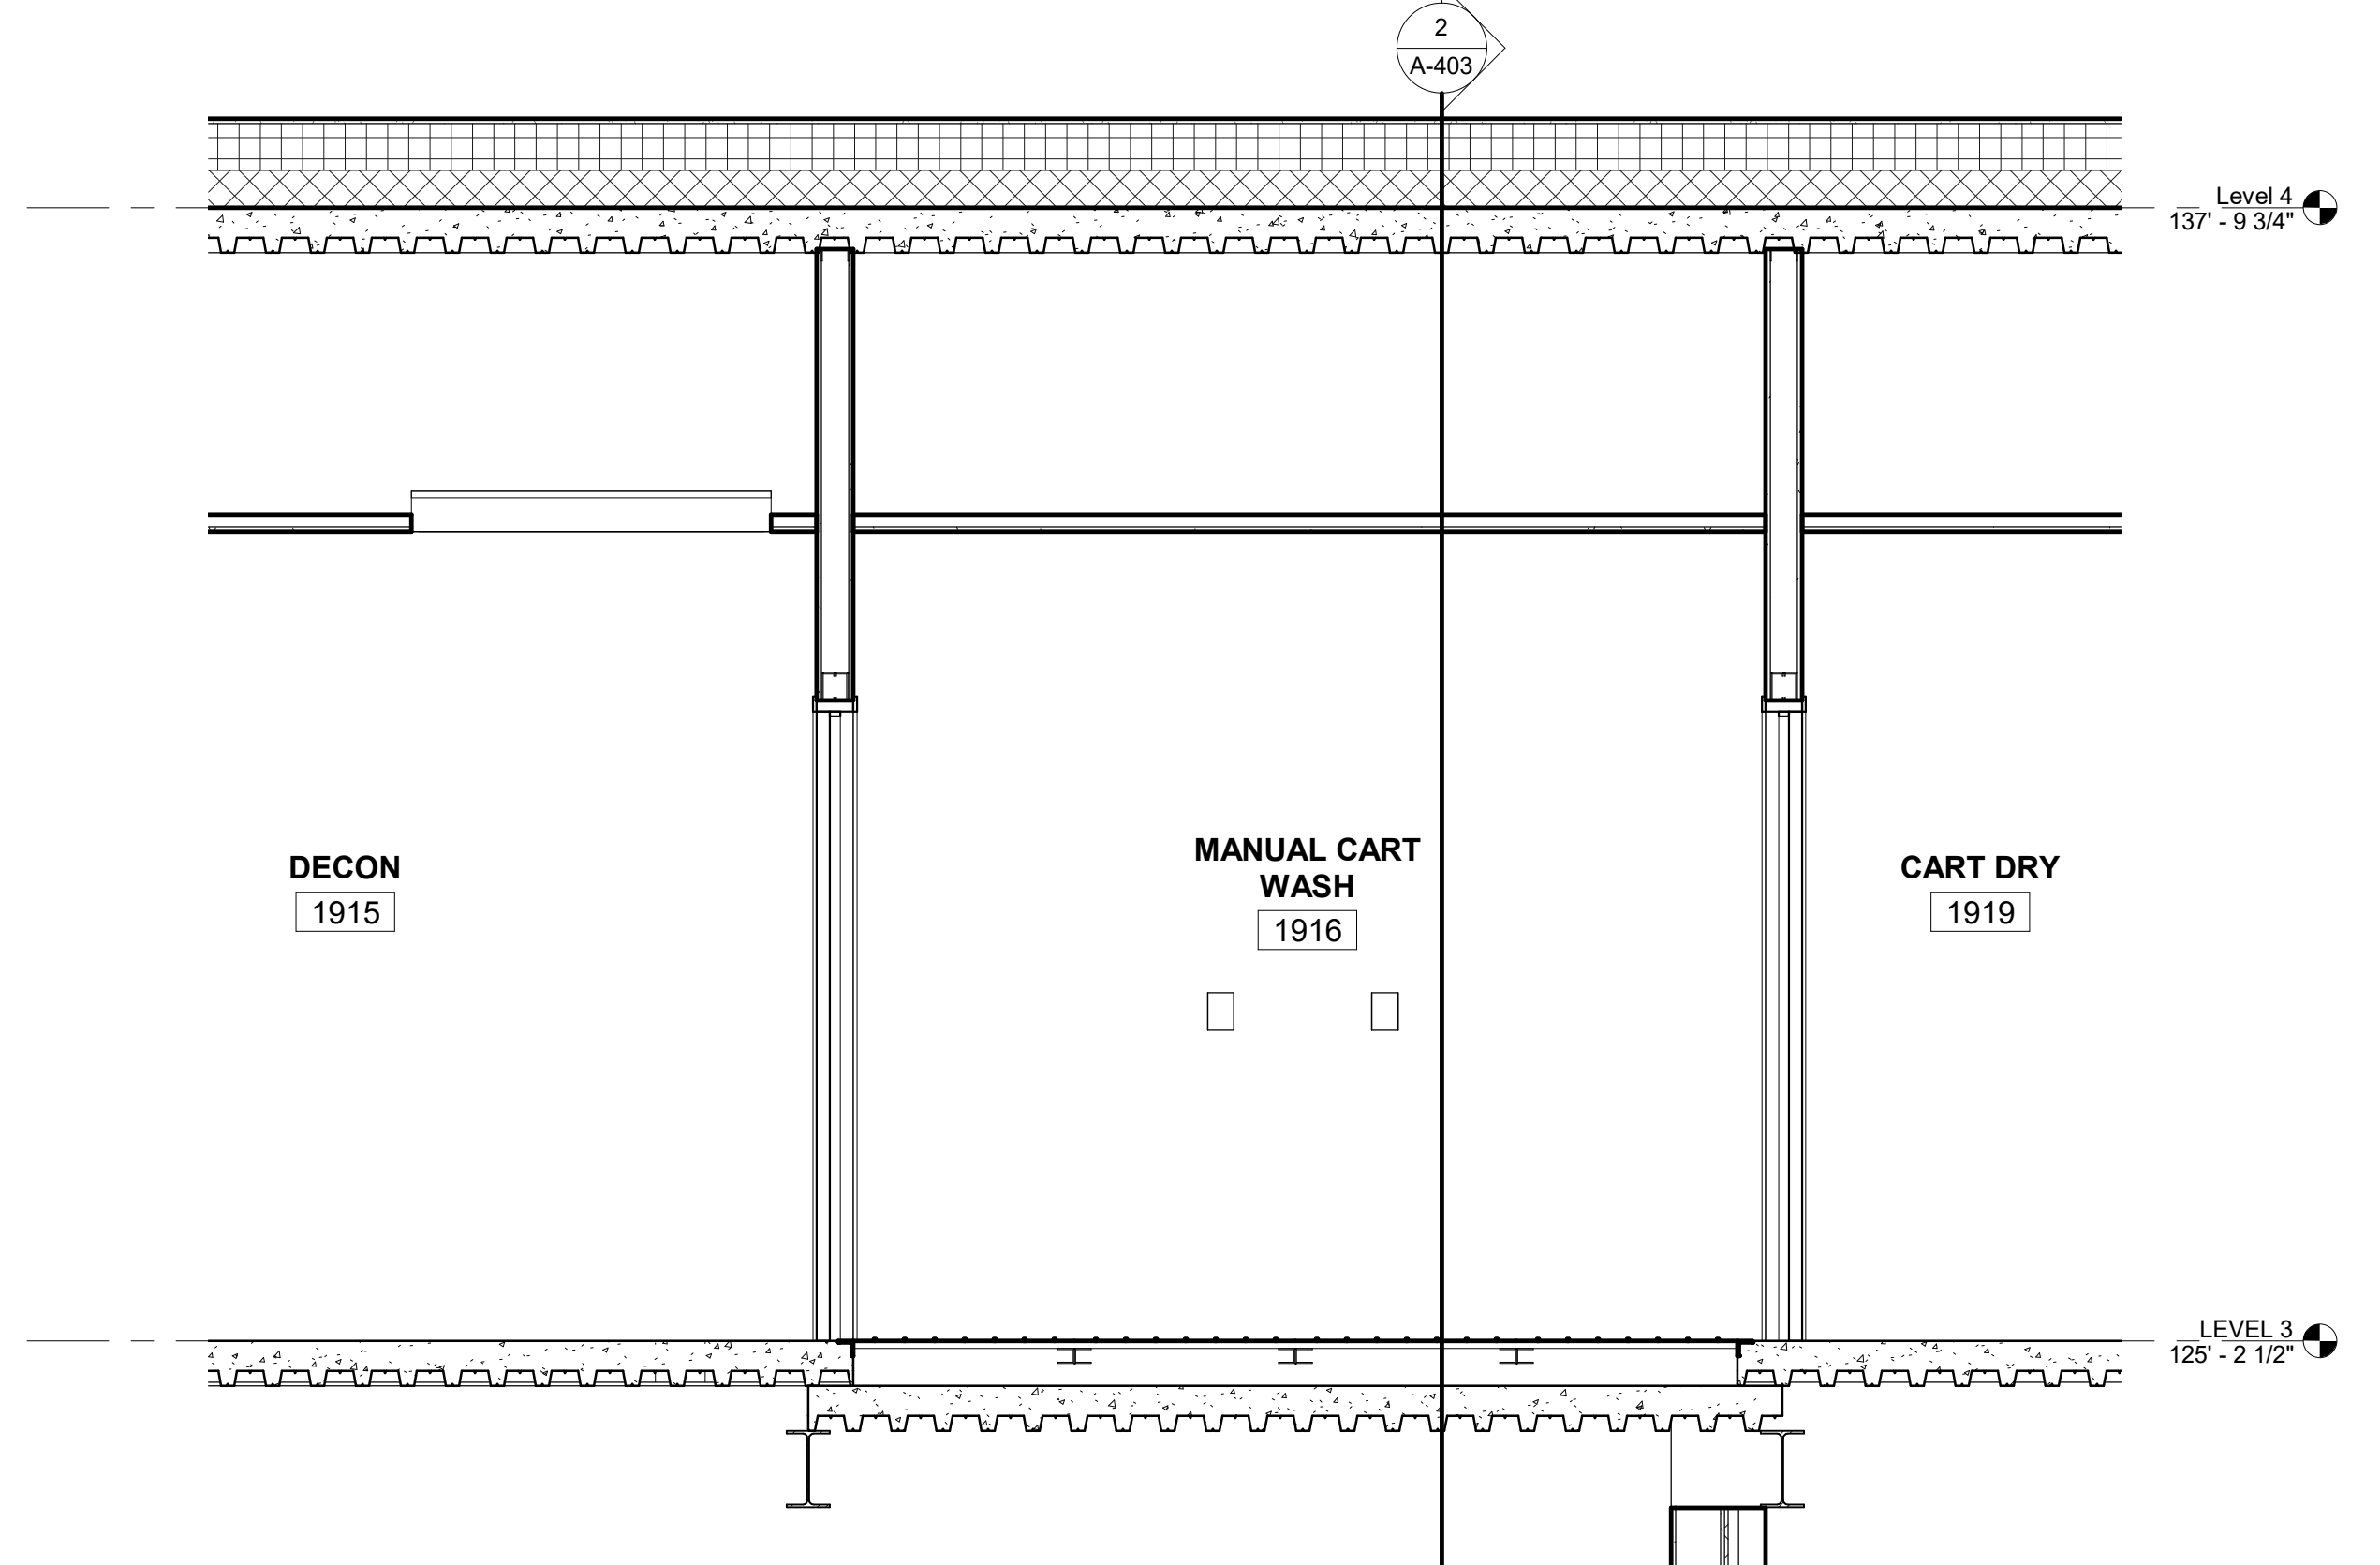

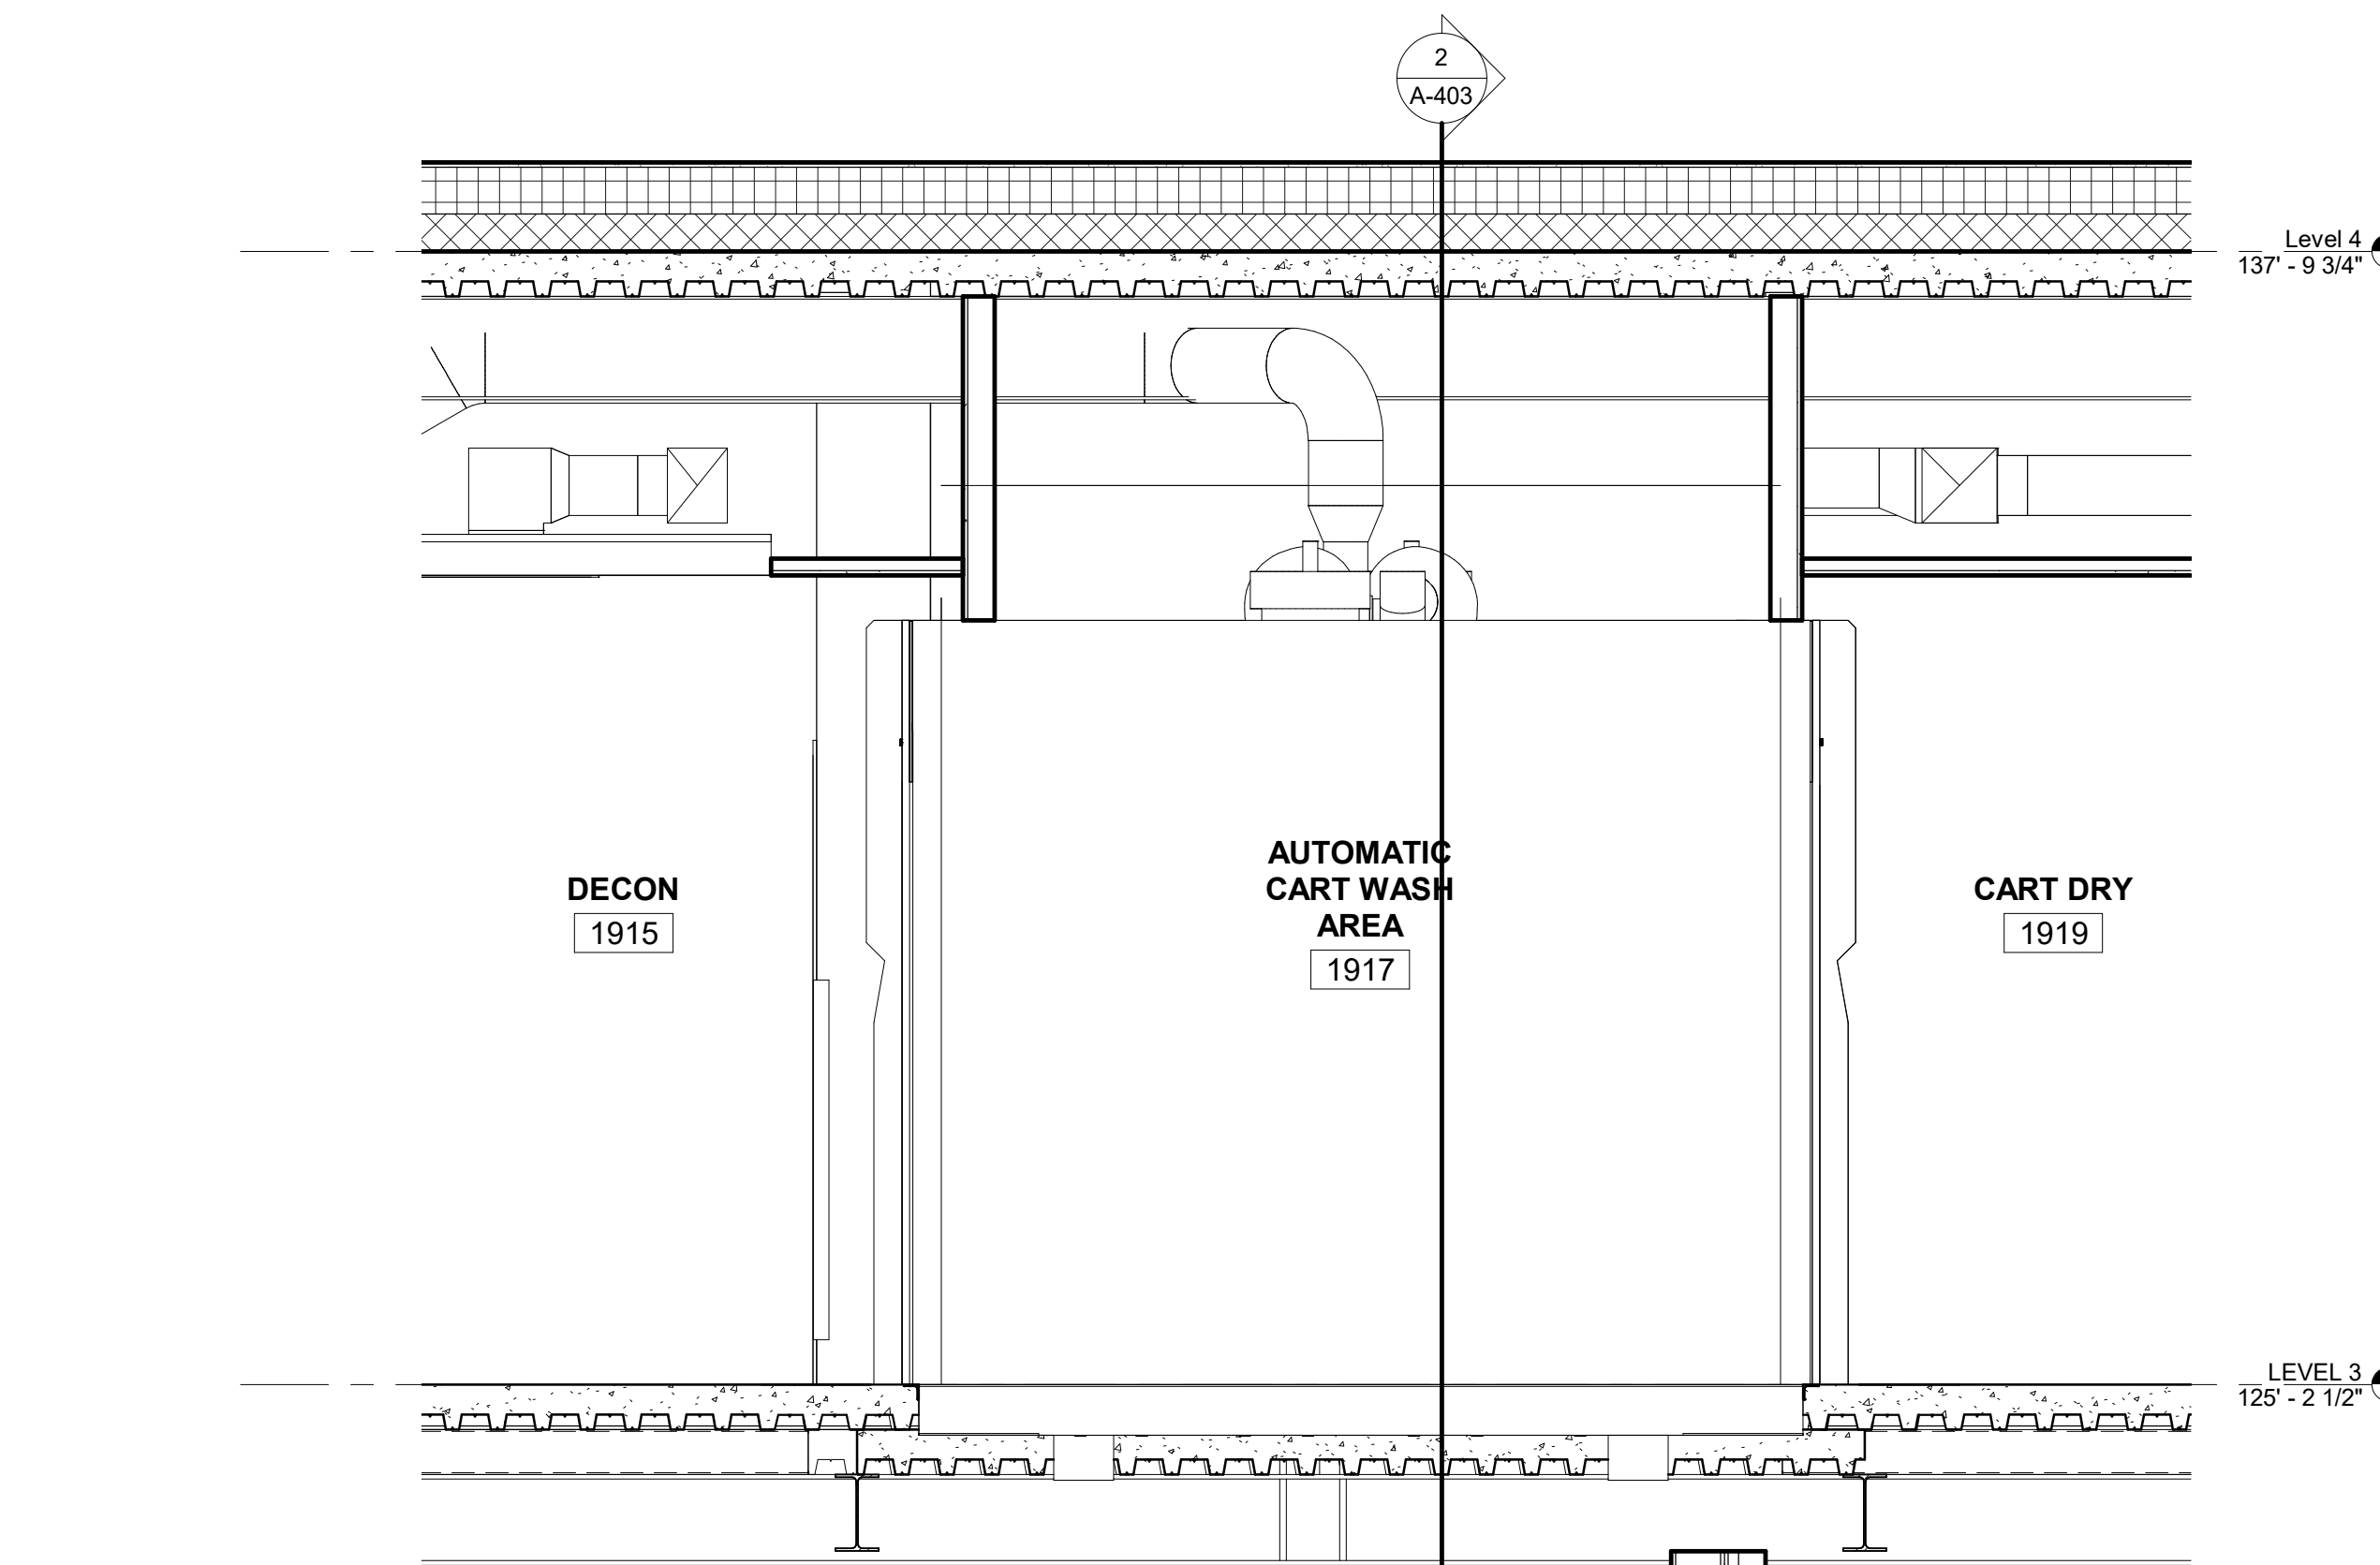3 SECTION E/W 1916 MANUAL CART WASH
1/2" = 1'-0"



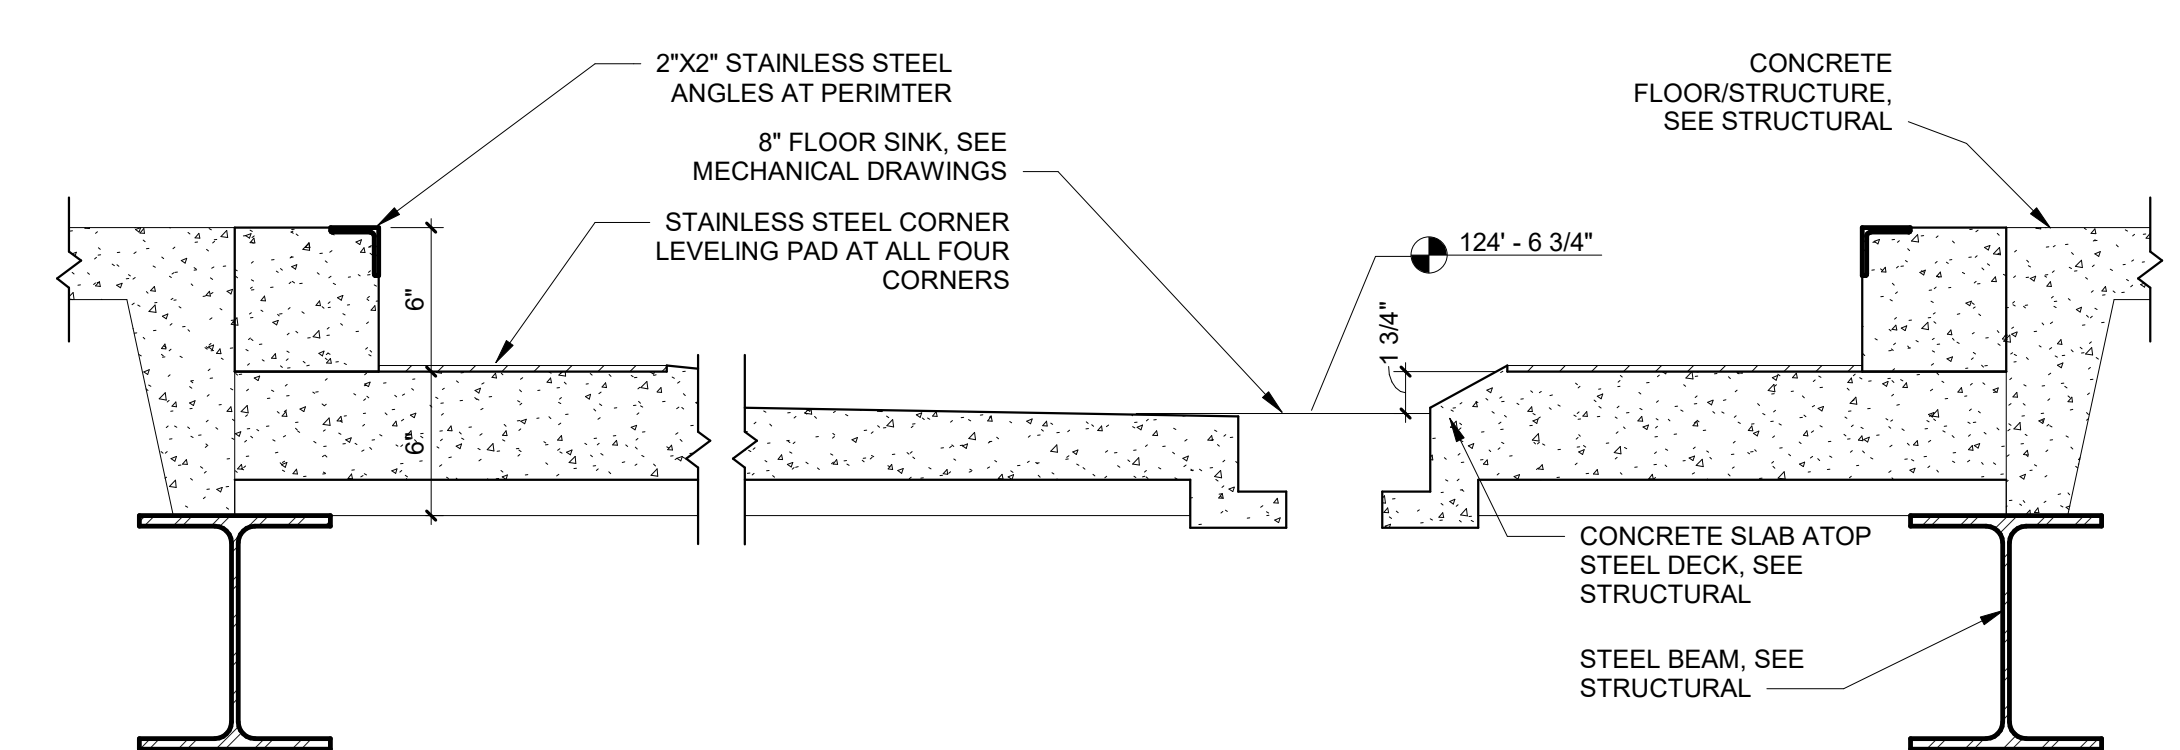4 SECTION E/W 1917-1918 AUTO CART WASH
1/2" = 1'-0"



5 DEPRESSED SLAB DETAIL
1 1/2" = 1'-0"

GENERAL NOTES:

1. SHEET SIZE FOR PROPER SCALE IS 30X42. CONTRACTOR SHALL NOT SCALE DRAWINGS BUT SHALL REQUEST THE DESIRED DIMENSIONS FROM THE ARCHITECT.
2. SEE SHEET C-002 FOR GENERAL NOTES.
3. APPLY 1 1/2" THICK FIREPROOFING AT ALL EXPOSED STEEL WITHIN INTERSTITIAL SPACE AND AT EXPOSED STEEL STRUCTURE ABOVE 3RD FLOOR CEILING, TYP.

SHEET SPECIFIC NOTES:

1. ALL CEILING HEIGHTS ARE 9'-0" AFF UNLESS NOTED OTHERWISE.
2. CEILING FIXTURES SHOWN REFERENCE ON REFER TO MECHANICAL / ELECTRICAL DRAWINGS.
3. REFER TO A-000 AND A-101 FOR PARTITION TYPES.
4. REFER TO FLOOR FINISH PLAN ON A-511 FOR FLOORING AT CART WASH AREAS.

CONSTRUCTION DOCUMENTS

COMPLIANCY REVIEW INCLUDED	2/23/2024
Revisions:	Date

CONSULTANTS:

TERRASITE DESIGN
1635 DEADWOOD AVENUE
RAPID CITY, SOUTH DAKOTA 57702
PH: (605) 791-1736

Albertson Engineering Inc.

ALBERTSON ENGINEERING, INC.
315 NORTH MAIN AVENUE, SUITE 200
SIOUX FALLS, SOUTH DAKOTA 57104
PH: (605) 274-0880

FARRIS ENGINEERING
OMAHA (BRANCH) 801111 COLORED PENCIL
FARRIS ENGINEERING
12700 WEST DODGE ROAD
OMAHA, NEBRASKA 68154
PH: (402) 330-5900



ARCHITECT

FOURFRONT DESIGN, INC.
517 7TH STREET
RAPID CITY, SOUTH DAKOTA
57701
PH: (605) 342-9470
FAX: (605) 342-2377
WWW.FOURFRONTDESIGN.COM

Drawing Title
CART WASH DETAILS
Approved: Project Director
Omaha VA Medical Center

Project Title
Design/Construct Sterile Processing Service- Omaha VA Medical Center
Location
4101 Woolworth Ave #4199 Omaha, Ne 68105
Date
11/23/2020
Checked
JL
Drawn
JGC

Project Number
16.2330.A08
Building Number
25
Drawing Number
A-404
Dwg. 63 of 193

Office of
Construction
and Facilities
Management



ROOM FINISH SCHEDULE LEGEND:

MATERIAL DESCRIPTION:

AT ACOUSTIC CEILING TILE
CONC CONCRETE, SEALED
CPT CARPET TILE
EPV EPOXY COATED CONCRETE
EXP EXPOSED
GWB GYPSUM WALL BOARD
P-1A SCUFFMASTER PAINT
P1 PAINT 1
P2 PAINT 2
P3 PAINT 3
PT-1 PORCELAIN TILE 1
PT-2 PORCELAIN TILE 2
PT-3 PORCELAIN TILE 3
RB RUBBER BASE
RES-W RESINOUS WALL COATING
RES-6 RESINOUS FLOORING LEVEL 6A
RF RUBBER FLOORING - STAIR SYSTEM
RWC RIGID WALL PROTECTION PANEL
SC-1 SPECIALTY COATING
SC-2 SPECIALTY COATING (UV)


TOILET ACCESSORY SCHEDULE	
A	42" GRAB BAR
B	18" GRAB BAR
C	TOILET PAPER DISPENSER
D	36" GRAB BAR

GENERAL NOTES:

- SHEET SIZE FOR PROPER SCALE IS 30X42. CONTRACTOR SHALL NOT SCALE DRAWINGS BUT SHALL REQUEST THE DESIRED DIMENSIONS FROM THE ARCHITECT.
- SEE SHEET G-002 FOR GENERAL NOTES.
- APPLY 1 1/2" THICK FIREPROOFING AT ALL EXPOSED STEEL WITHIN INTERSTITIAL SPACE AND AT EXPOSED STEEL STRUCTURE ABOVE 3RD FLOOR CEILING, TYP.






SHEET SPECIFIC NOTES:

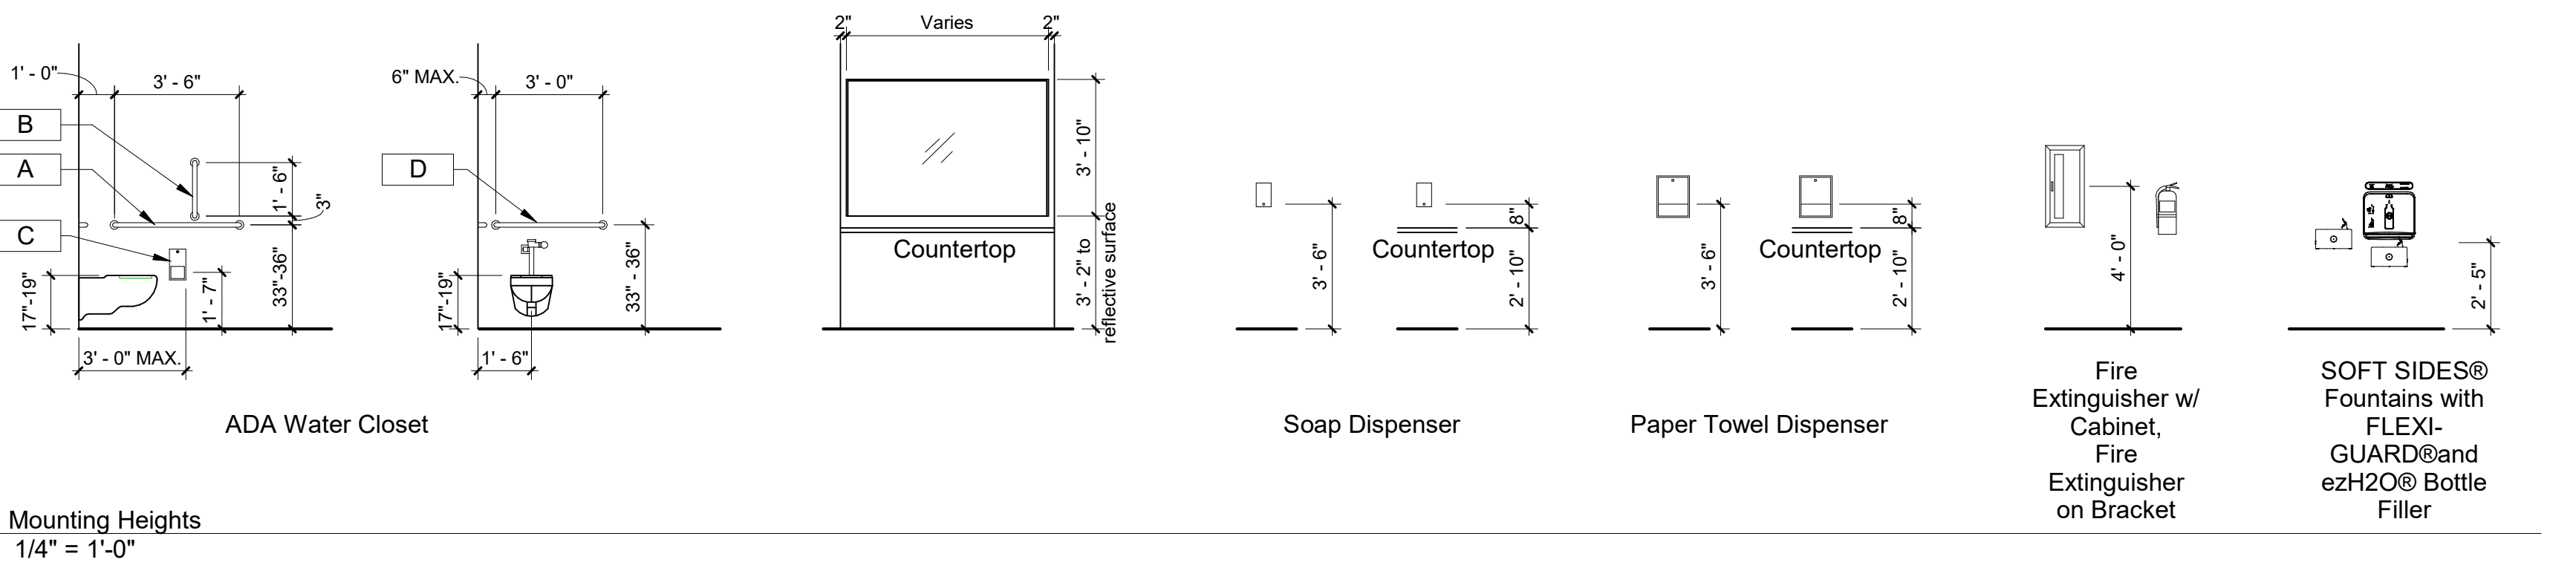- SEE WALL PROTECTION PLAN FOR SPECIFIC LOCATIONS OF WALL PANELS, CORNER GUARDS, BUMPER RAILS AND HANDRAILS.
- PORCELAIN TILE, SOLID SURFACING, RESINOUS WALL APPLICATION OVER CONCRETE BACKER BOARD. SEE SPECIFICATIONS.
- COORDINATE SHOWER STALL AND FLOOR LAYOUTS BASED ON DIMENSIONS OF SHOWER FLOOR MANUFACTURER'S ROUGH-IN REQUIREMENTS.



1 Mounting Heights
1/4" = 1'-0"

ROOM FINISH SCHEDULE									
NUMBER	NAME	FLOOR FINISH	BASE FINISH	WALLS				CEILING FINISH	REMARKS
				NORTH	EAST	SOUTH	WEST		
1802	INTERSTITIAL SPACE	CONC	RB	P1	P1	P1	P1	EXP	
1802A	ELECTRICAL	CONC	RB	P1	P1	P1	P1	EXP	
1802B	ELECTRICAL	CONC	RB	P1	P1	P1	P1	EXP	
1802C	ELECTRICAL	CONC	RB	P1	P1	P1	P1	EXP	
1803	STAIRS	RF	RB	P1A	P1A	P1A	P1A	EXP	
1900	CORRIDOR	LVT1	RB	P1A/RWC	P1A/RWC	P1A/RWC	P1A/RWC	AT1	RWC 4'-0" ABOVE BASE; SEE SHEET A-512
1900A	CORRIDOR	LVT1	RB	P1A/RWC	P1A/RWC	P1A/RWC	P1A/RWC	AT1	RWC 4'-0" ABOVE BASE; SEE SHEET A-512
1900B	CORRIDOR	LVT1	RB	P1A/RWC	P1A/RWC	P1A/RWC	P1A/RWC	AT1	RWC 4'-0" ABOVE BASE; SEE SHEET A-512
1901	OPEN SPACE	LVT1	RB	SC-2	SC-2	SC-2	SC-2	SC-2	
1902	IT	LVT1	RB	P1	P1	P1	P1	EXP	
1902A	MECH. CHASE								
1903	ANTEROOM, SOILED TRANSITION / DROP-OFF	RES-6	RES-6	RES-W1	RES-W1	RES-W1	RES-W1	RES-W1	
1904	SCOPE DROP OFF	RES-6	RES-6	SC1	SC1	SC1	SC1	SC1	
1905	SCOPE PROC	RES-6	RES-6	SC1	SC1	SC1	SC1	SC1	
1906A	SCOPE ANTE	RES-6	RES-6	RES-W1	RES-W1	RES-W1	RES-W1	RES-W1	
1906B	SCOPE STG	RES-6	RES-6	SC1	SC1	SC1	SC1	SC1	
1907	WOMEN'S LOCKER	PT1	PT2	RWC/SC1	RWC/SC1	RWC/SC1	RWC/SC1	AT1	RWC 4'-0" AFF
1907A	WOMEN'S RR	PT1	PT2	PT2/SC1	PT2/SC1	PT2/SC1	PT2/SC1	SC1	
1907B	WOMEN'S RR	PT1	PT2	PT2/SC1	PT2/SC1	PT2/SC1	PT2/SC1	SC1	
1907C	WOMEN'S SHOWER	PT3	PT2	PT2/SC1	PT2/SC1	PT2/SC1	PT2/SC1	SOFFIT - SC1	
1908	MEN'S LOCKER	PT1	PT2	RWC/SC1	RWC/SC1	RWC/SC1	RWC/SC1	SOFFIT - AT1	RWC 4'-0" AFF
1908A	MEN'S RR	PT1	PT2	PT2/SC1	PT2/SC1	PT2/SC1	PT2/SC1	SC1	
1908B	MEN'S RR	PT1	PT2	PT2/SC1	PT2/SC1	PT2/SC1	PT2/SC1	SC1	
1908C	MEN'S SHOWER	PT3	PT2	PT2/SC1	PT2/SC1	PT2/SC1	PT2/SC1	SC1	
1909	BREAK ROOM	LVT1	RB	-	P1/RWC	P4	P1/RWC	AT1	
1910	OPEN OFFICE/TRAINING	LVT1	RB	P1/RWC	P1/RWC	-	P1/RWC	AT1	
1911	ANTE VENDOR DROP OFF	RES-6	RES-6	RES-W1	RES-W1	RES-W1	RES-W1	RES-W1	
1912	H2O	RES-6	RES-6	SC1	SC1	SC1	SC1	SC1	
1913	CART PASS	RES-6	RES-6	RWC/RES-W1	RWC/RES-W1	RWC/RES-W1	RWC/RES-W1	RES-W1	RWC 8'-0" AFF
1913A	MECH. CHASE								
1914	HAC	RES-6	RES-6	RWC/SC1	RWC/SC1	RWC/SC1	RWC/SC1	SC1	RWC 4' - 0" AFF WAINSCOT
1915	DECON	RES-6	RES-6	SC1	SC1	SC1	SC1	SC1	
1916	MANUAL CART WASH	RES-6	RES-6	PT2	PT2	PT2	PT2	SC1	
1917	AUTOMATIC CART WASH AREA	RES-6	RES-6					SC1	
1918	MECH CHASE								
1919	CART DRY	RES-6	RES-6	PT2/RES-W1	PT2/RES-W1	PT2/RES-W1	PT2/RES-W1	RES-W1	PT2 AT 6'-0" ABOVE BASE
1920	STERILIZATION	RES-6	RES-6	RES-W1	RES-W1	RES-W1	RES-W1	RES-W1	
1921	STERILE STG	RES-6	RES-6	SC1/RWC	SC1/RWC	SC1/RWC	SC1/RWC	SC1	RWC 8' - 0" AFF
1921A	MECH. CHASE								
1923	PREP ASSEMBLY	RES-6	RES-6	SC1	SC1	SC1	SC1	SC1	
1924	ANTE	RES-6	RES-6	RES-W1	RES-W1	RES-W1	RES-W1	RES-W1	
1925	HAC	RES-6	RES-6	RWC/SC1	RWC/SC1	RWC/SC1	RWC/SC1	RWC	RWC 4' - 0" AFF WAINSCOT
1926	SHELL SPACE	CONC	RB	P1	P1	P1	P1	EXP	
1931	STAIRS	RF	RB	P1A	P1A	P1A	P1A	EXP	

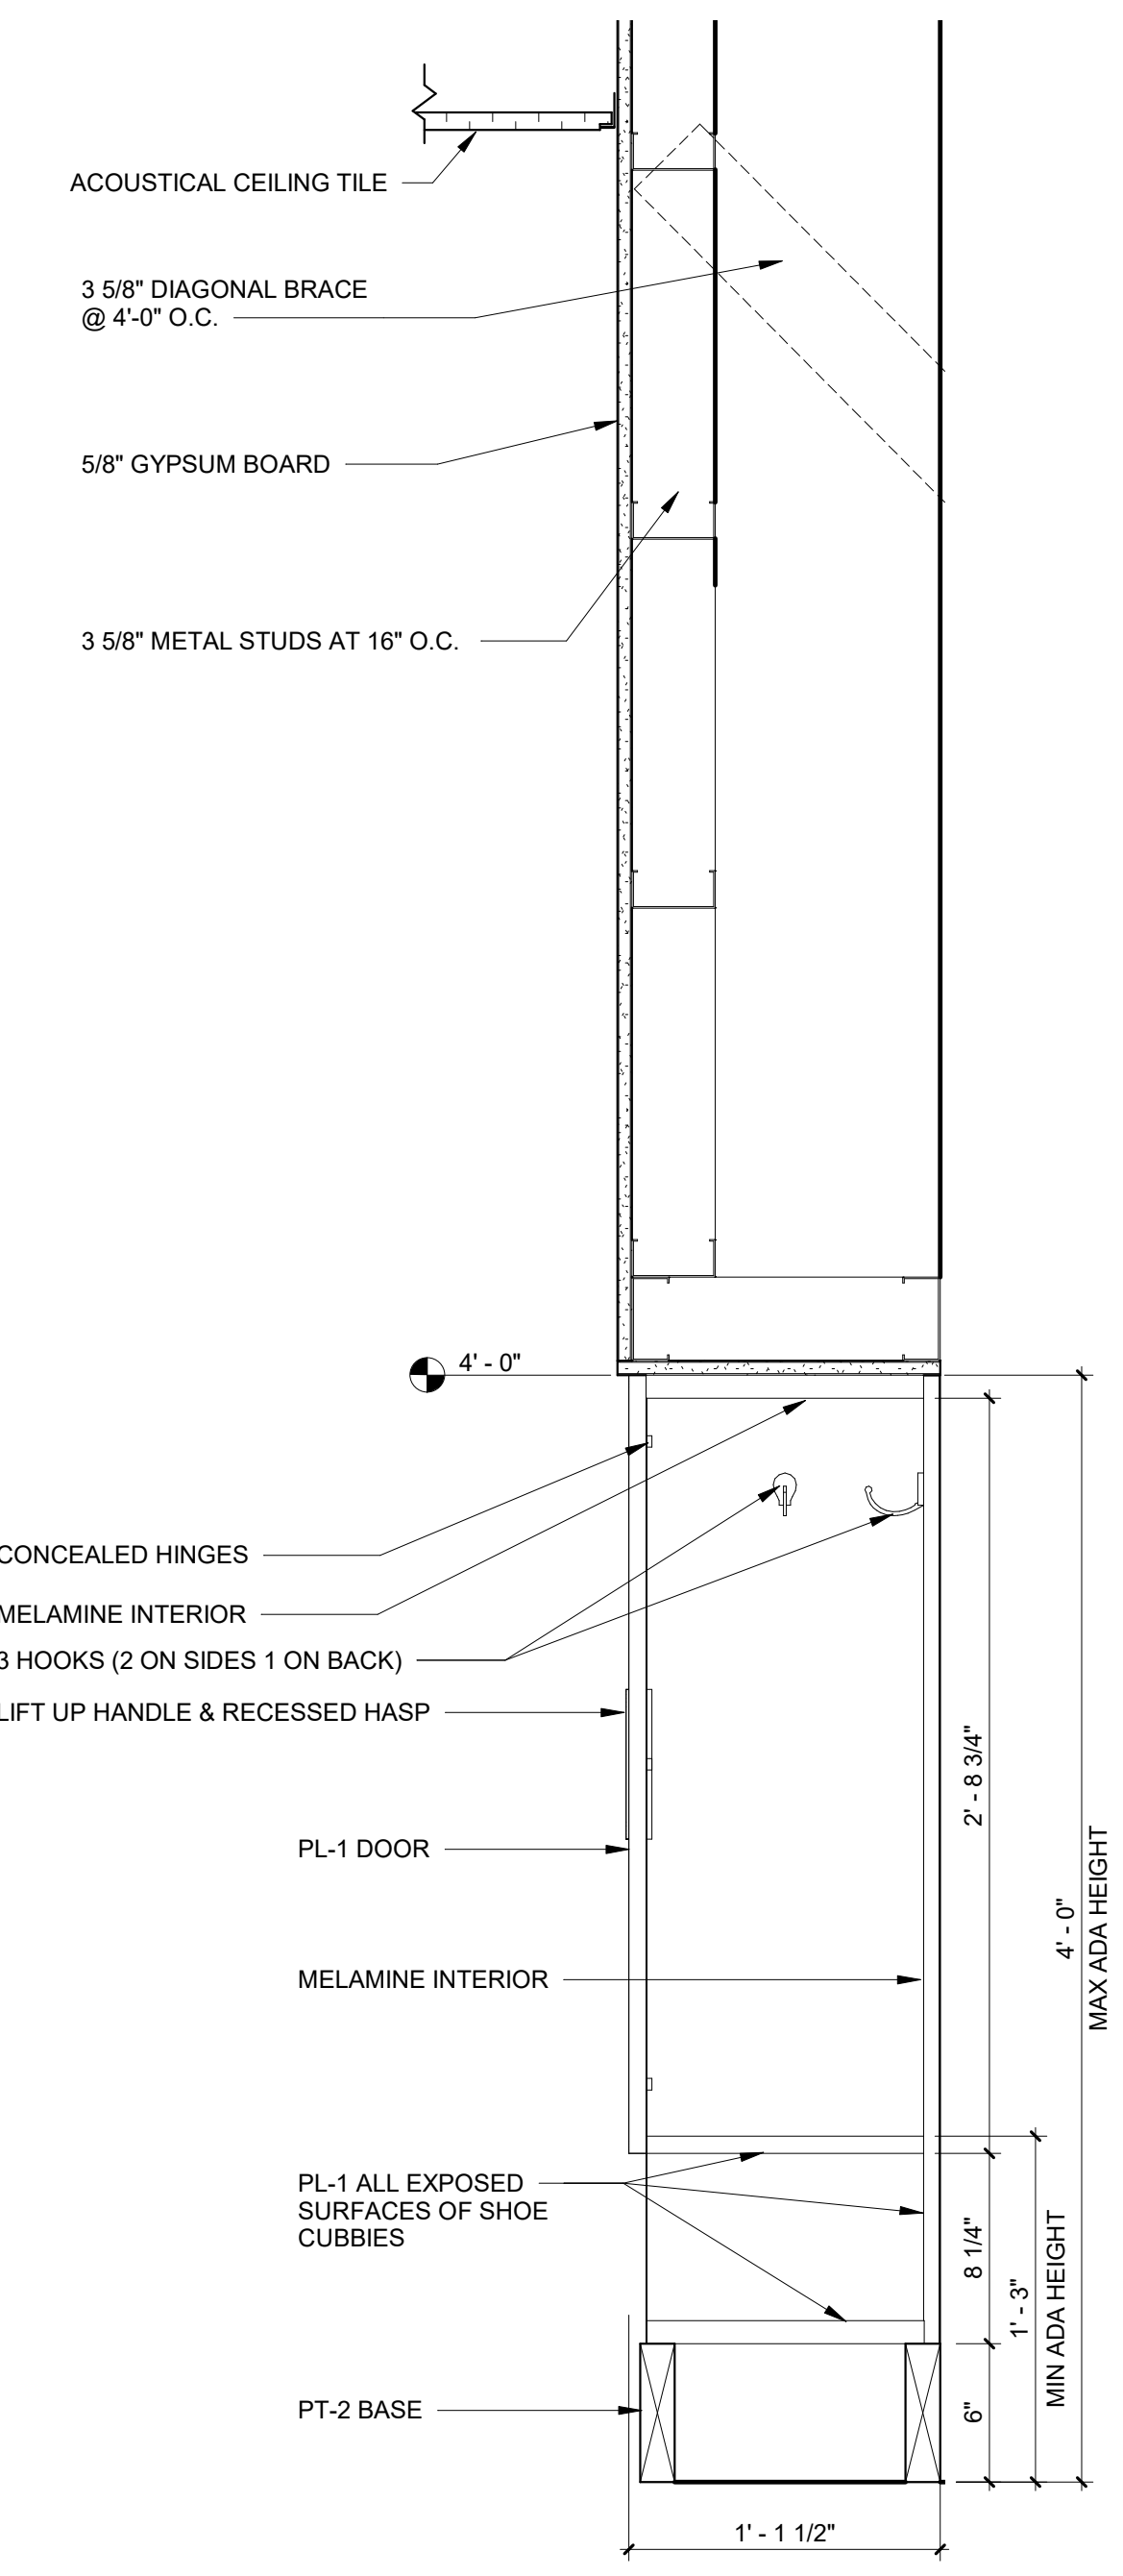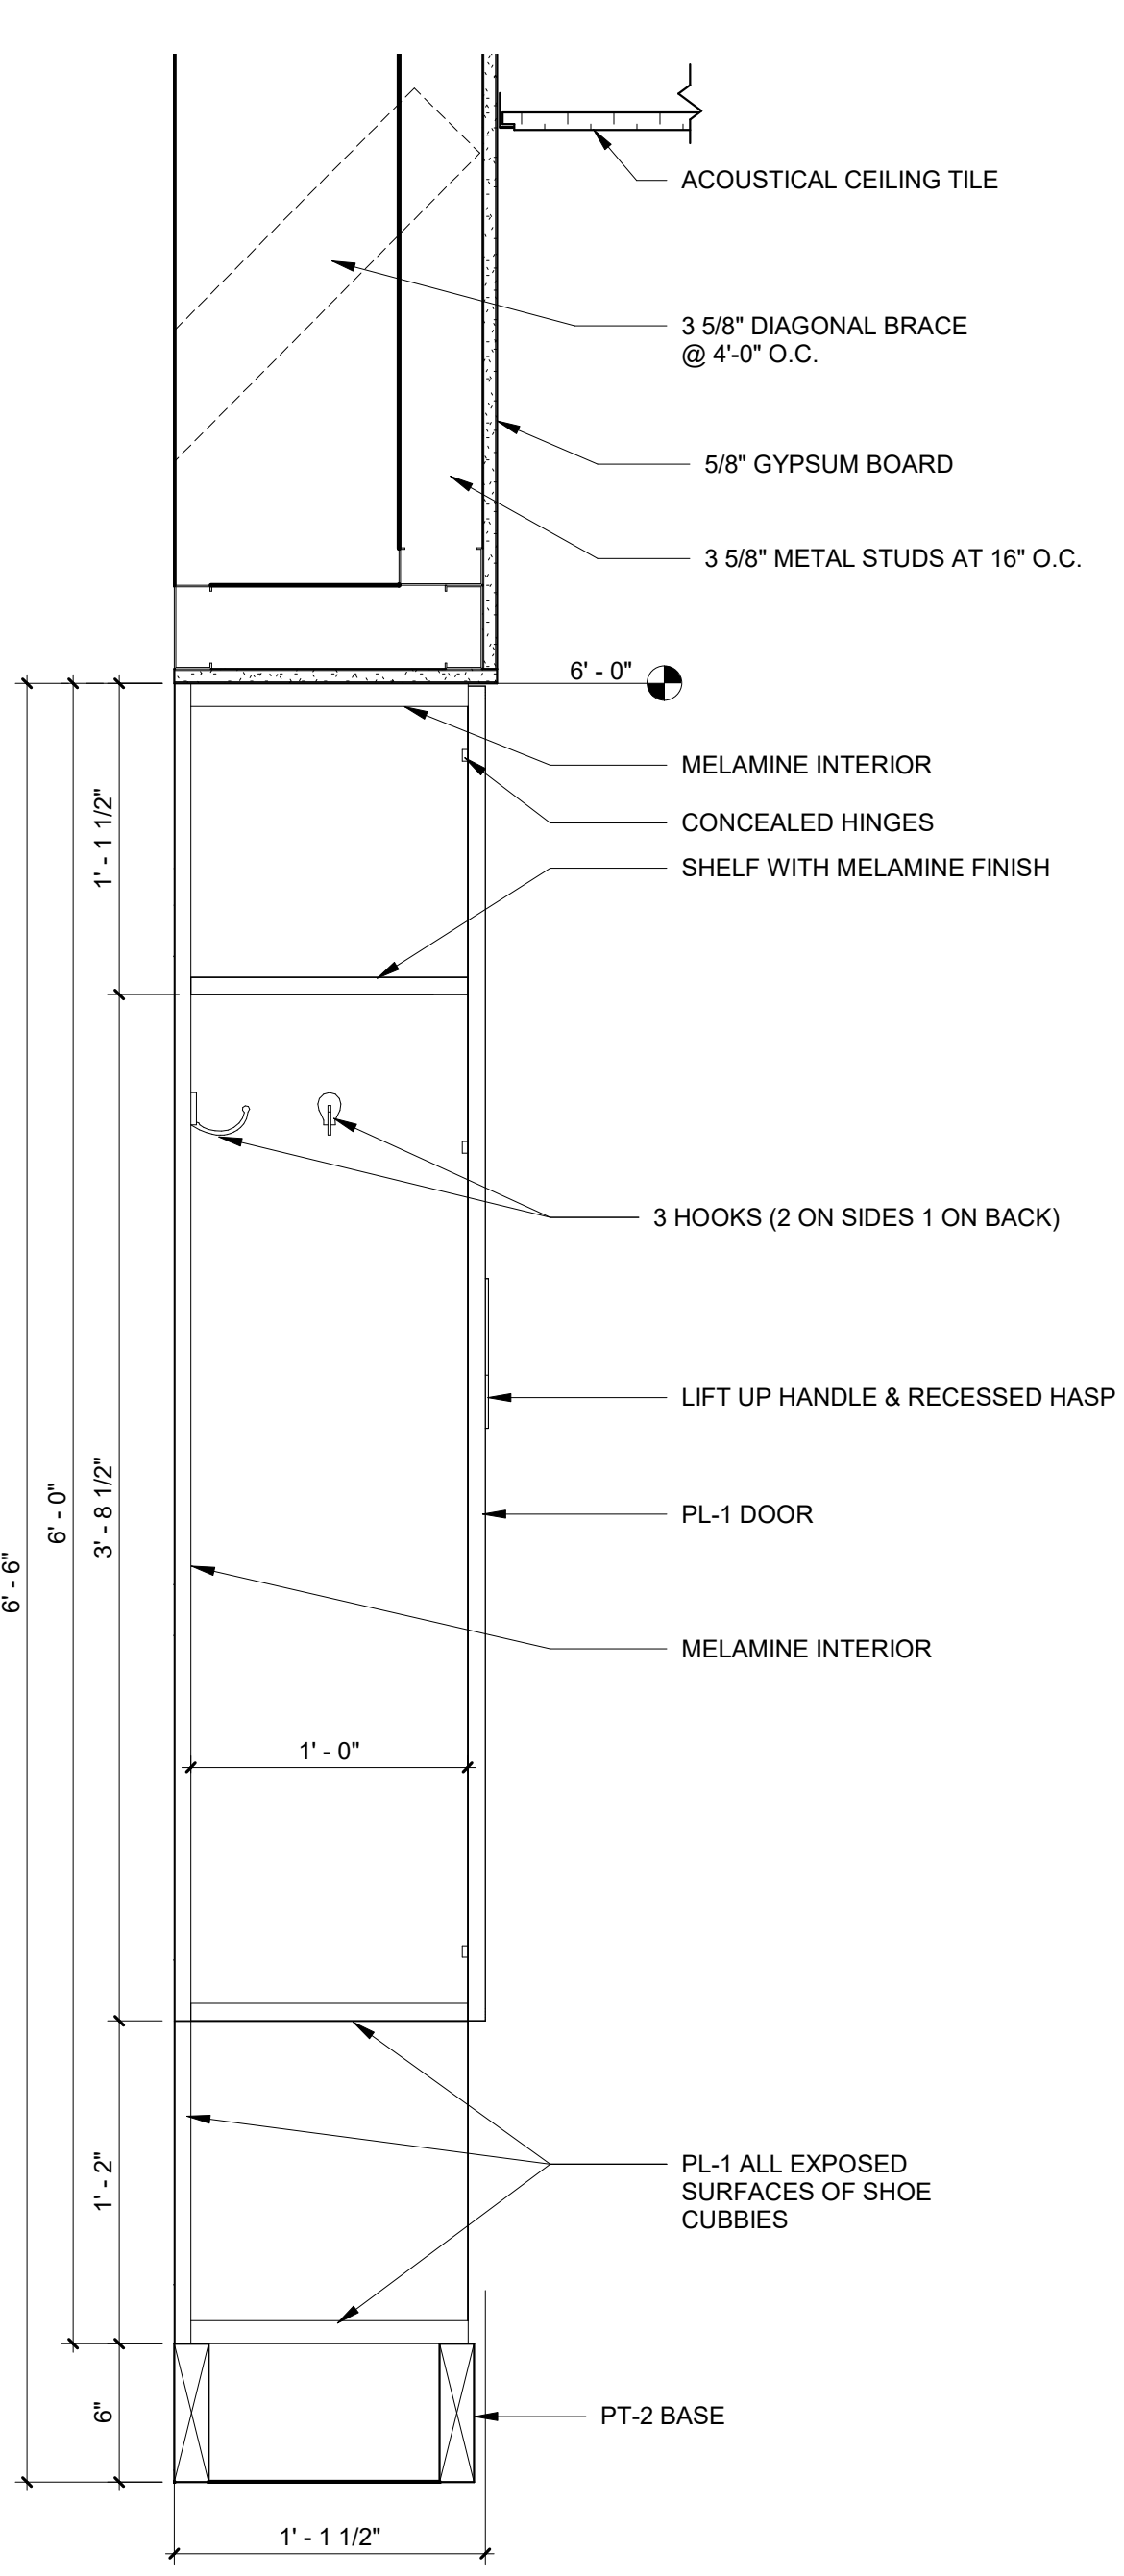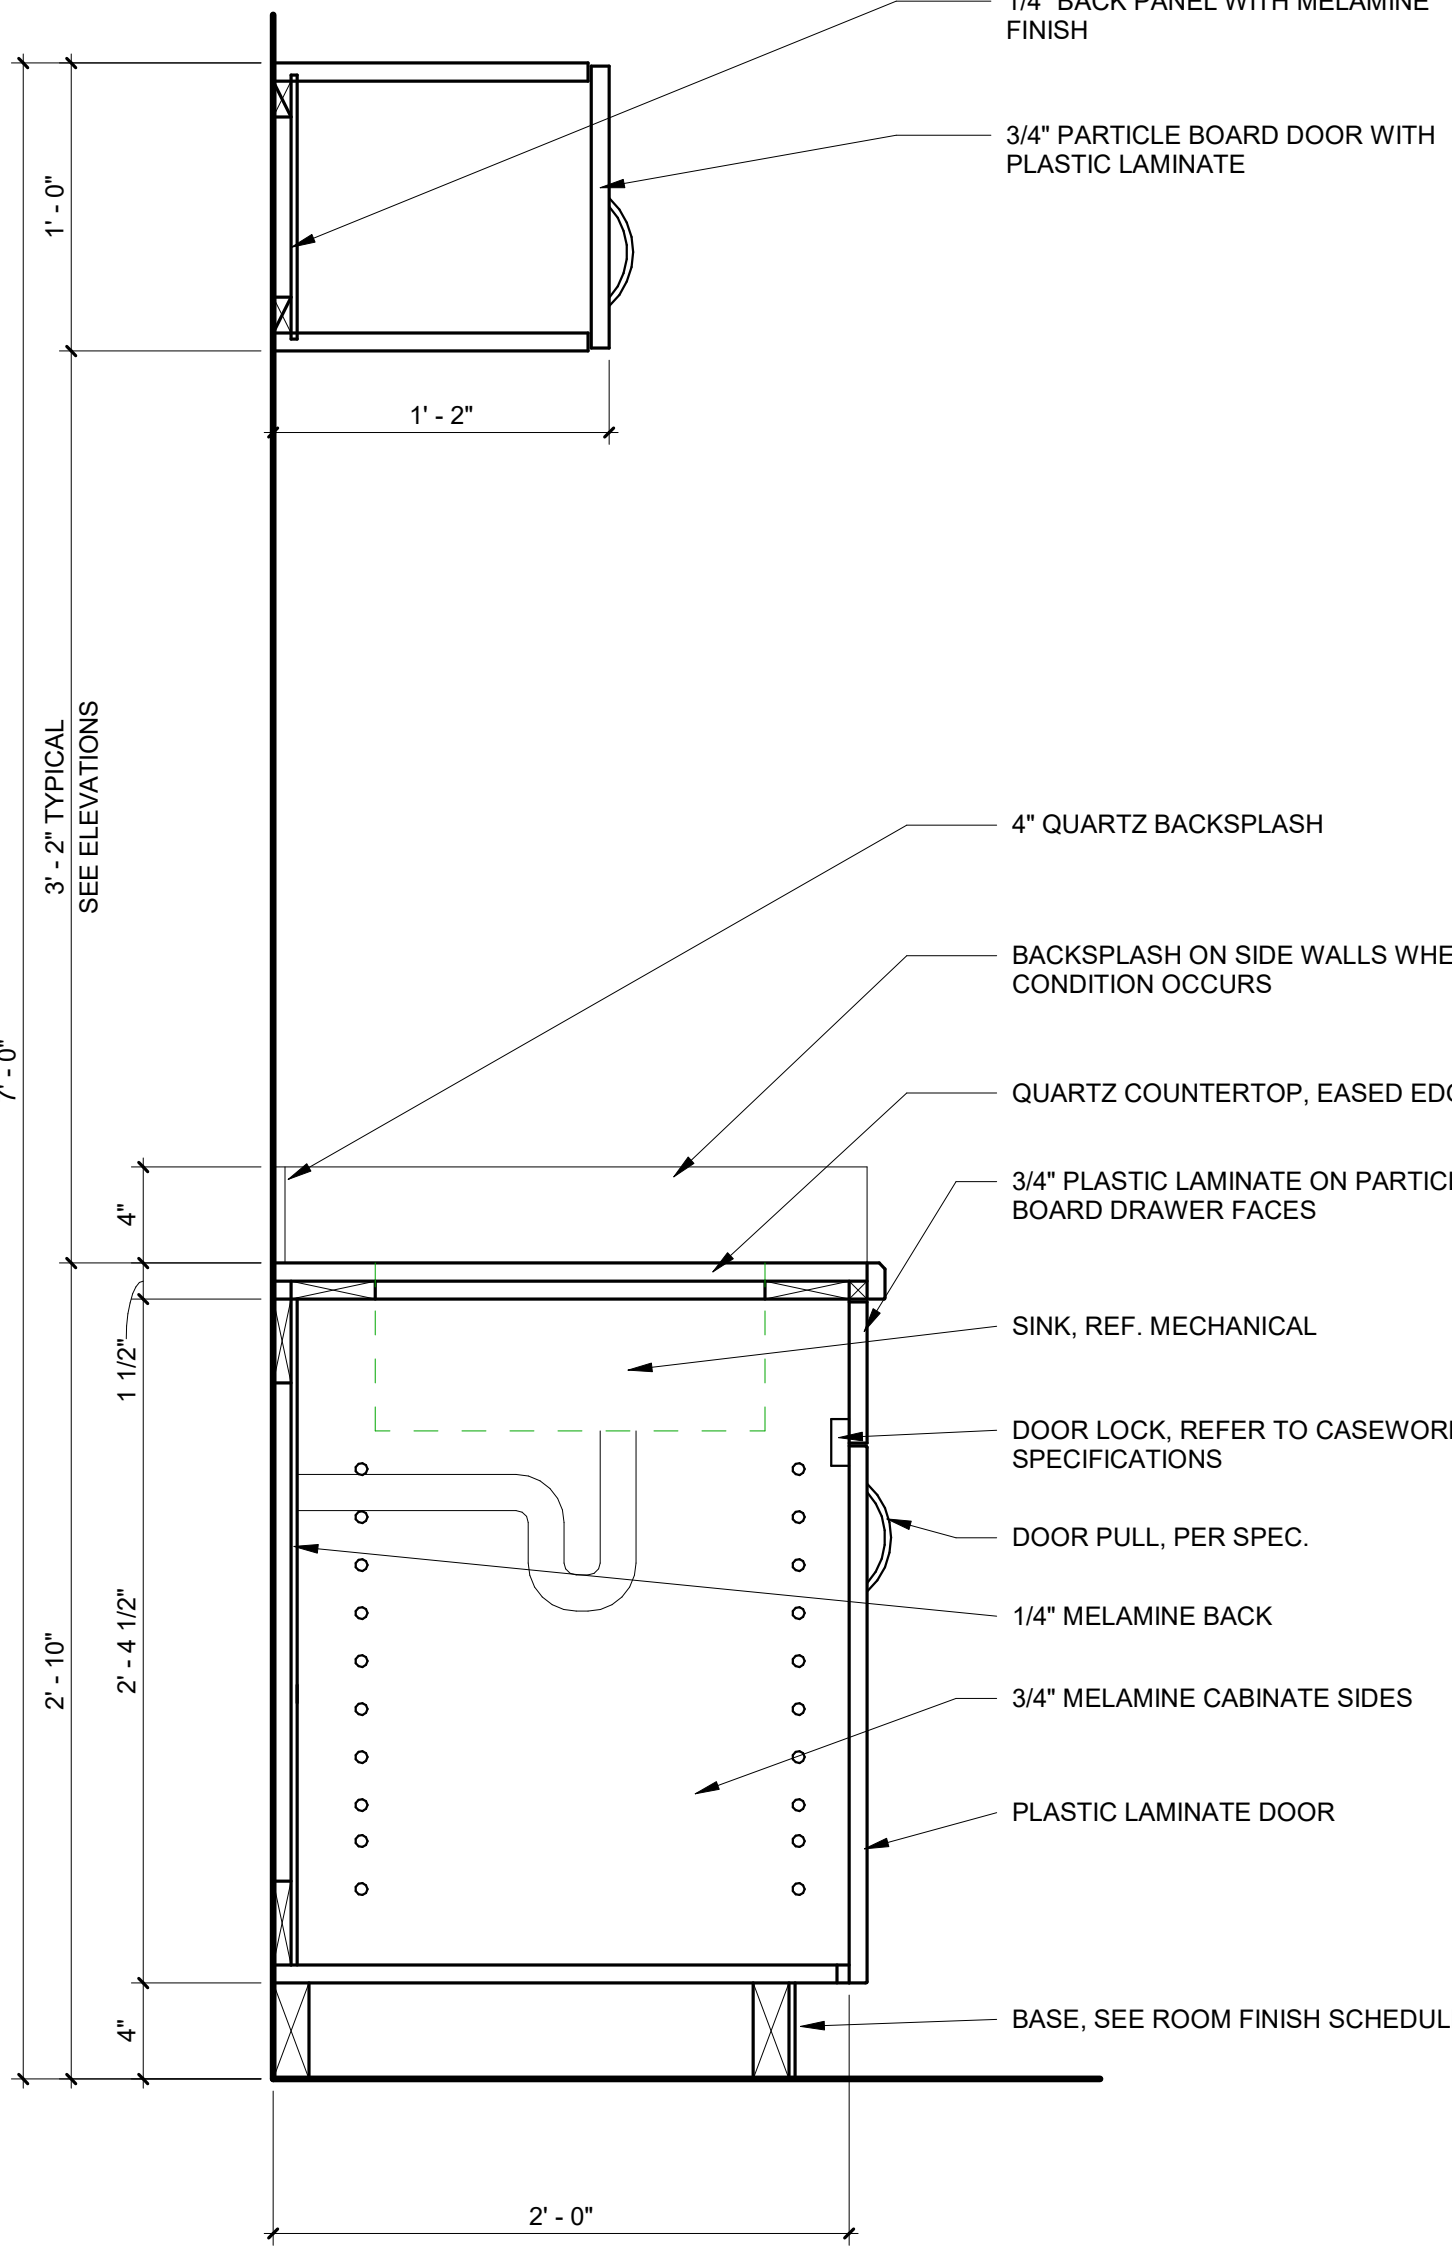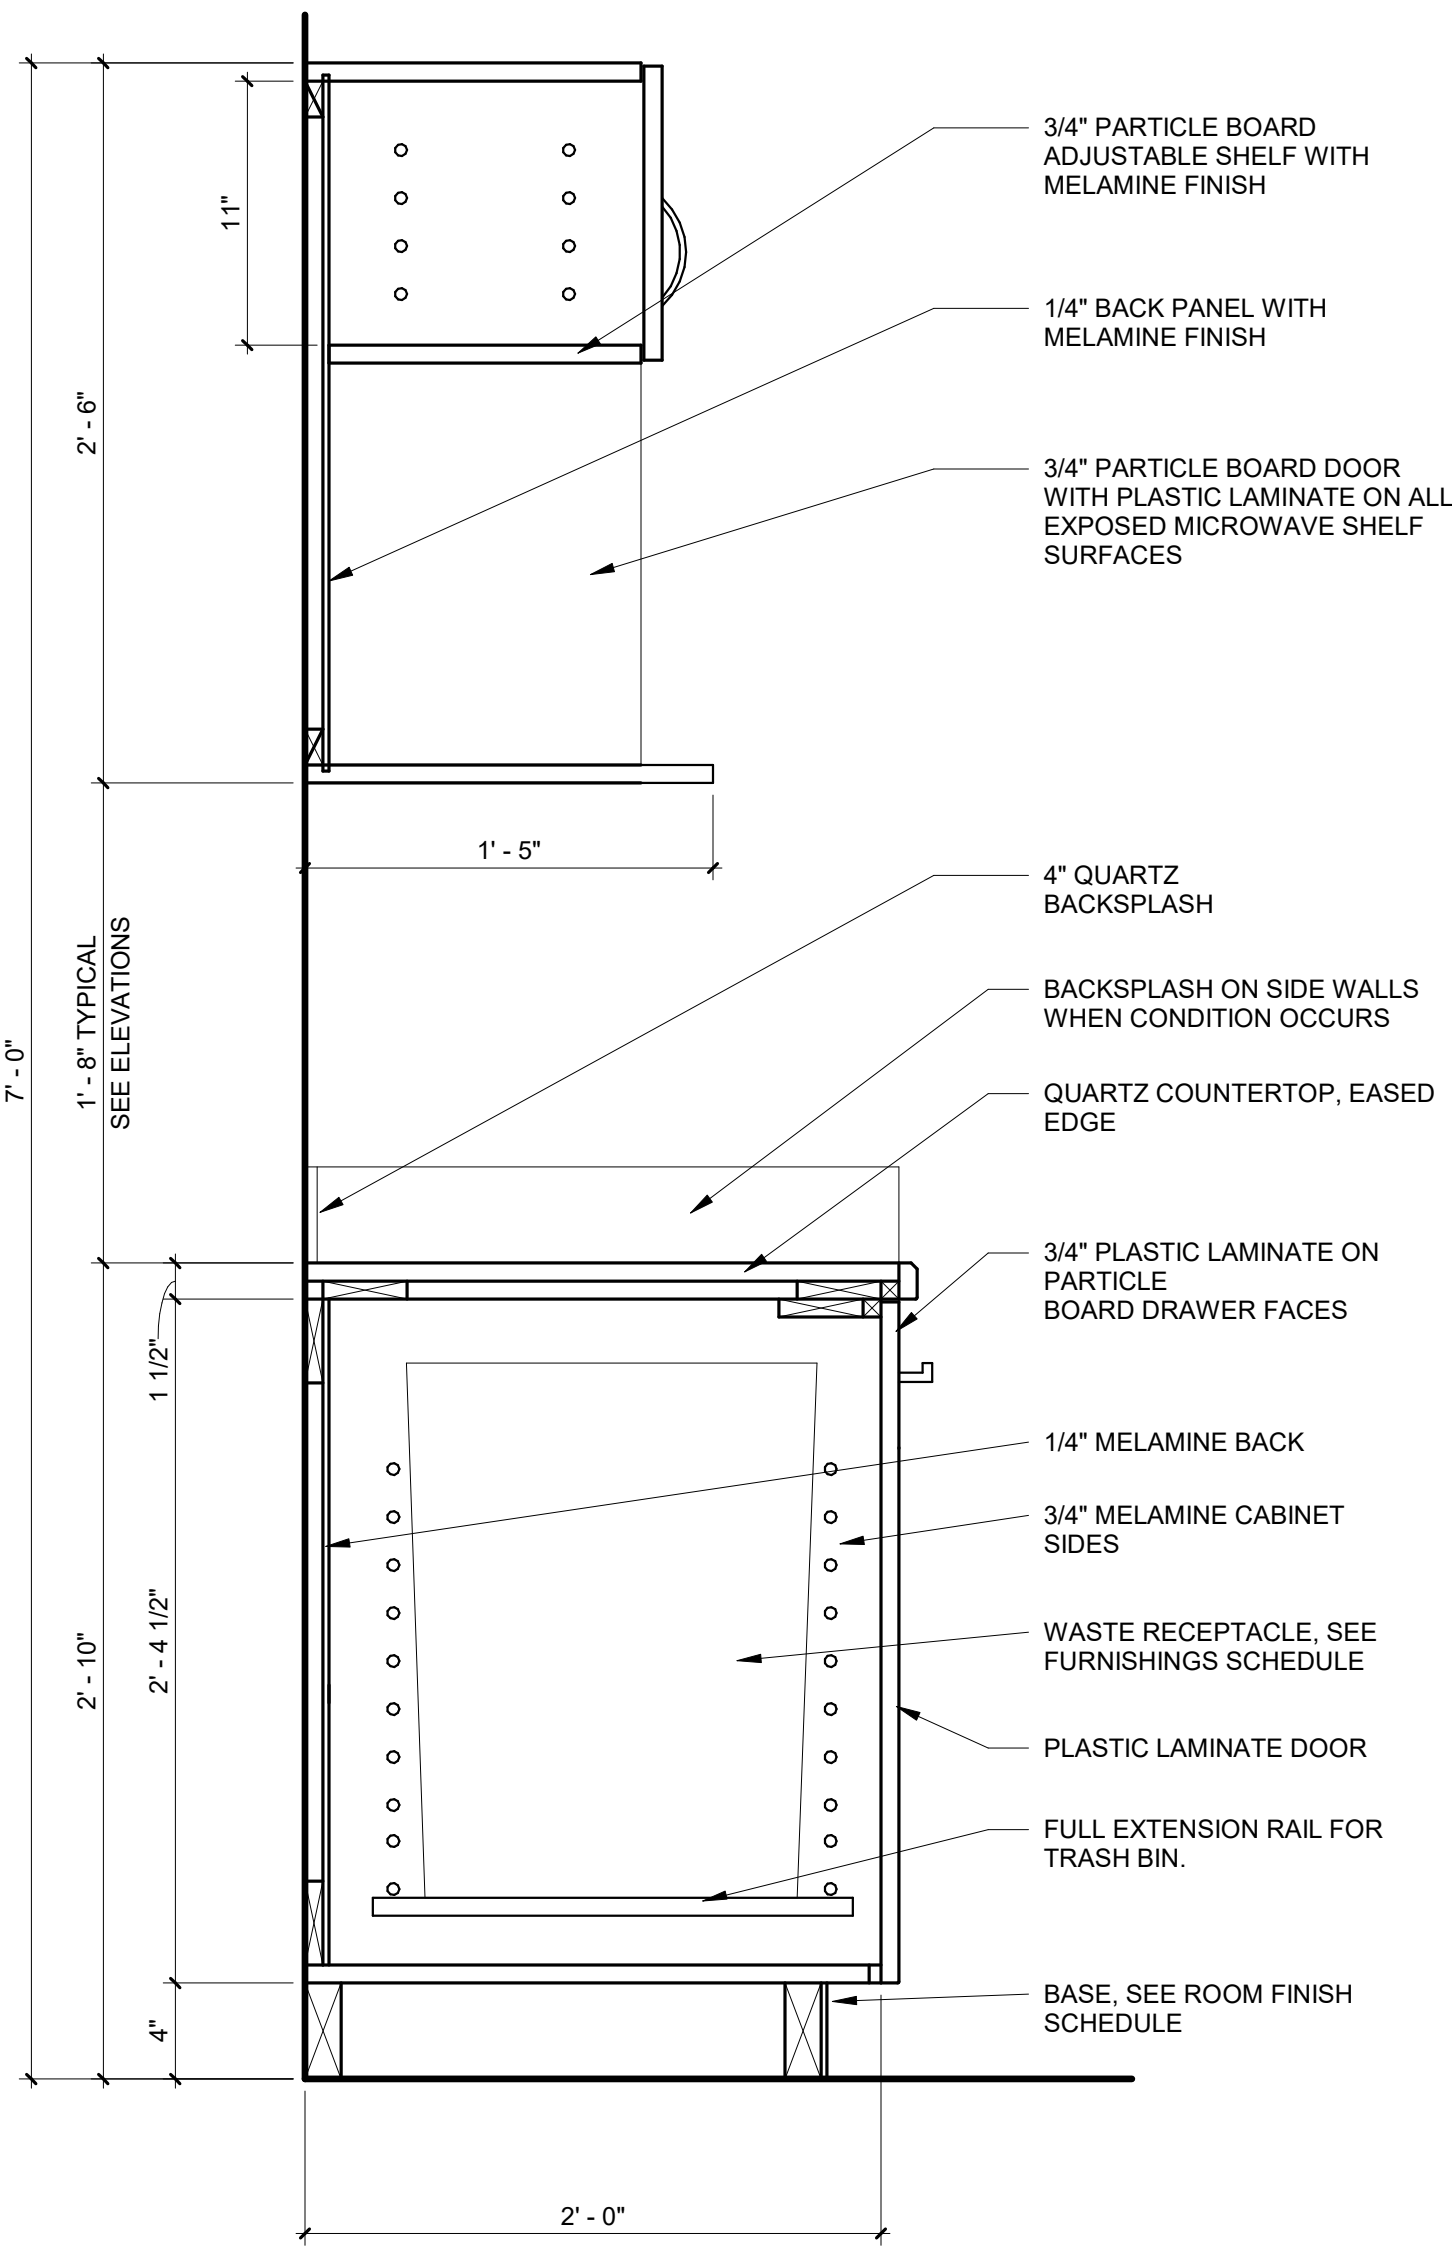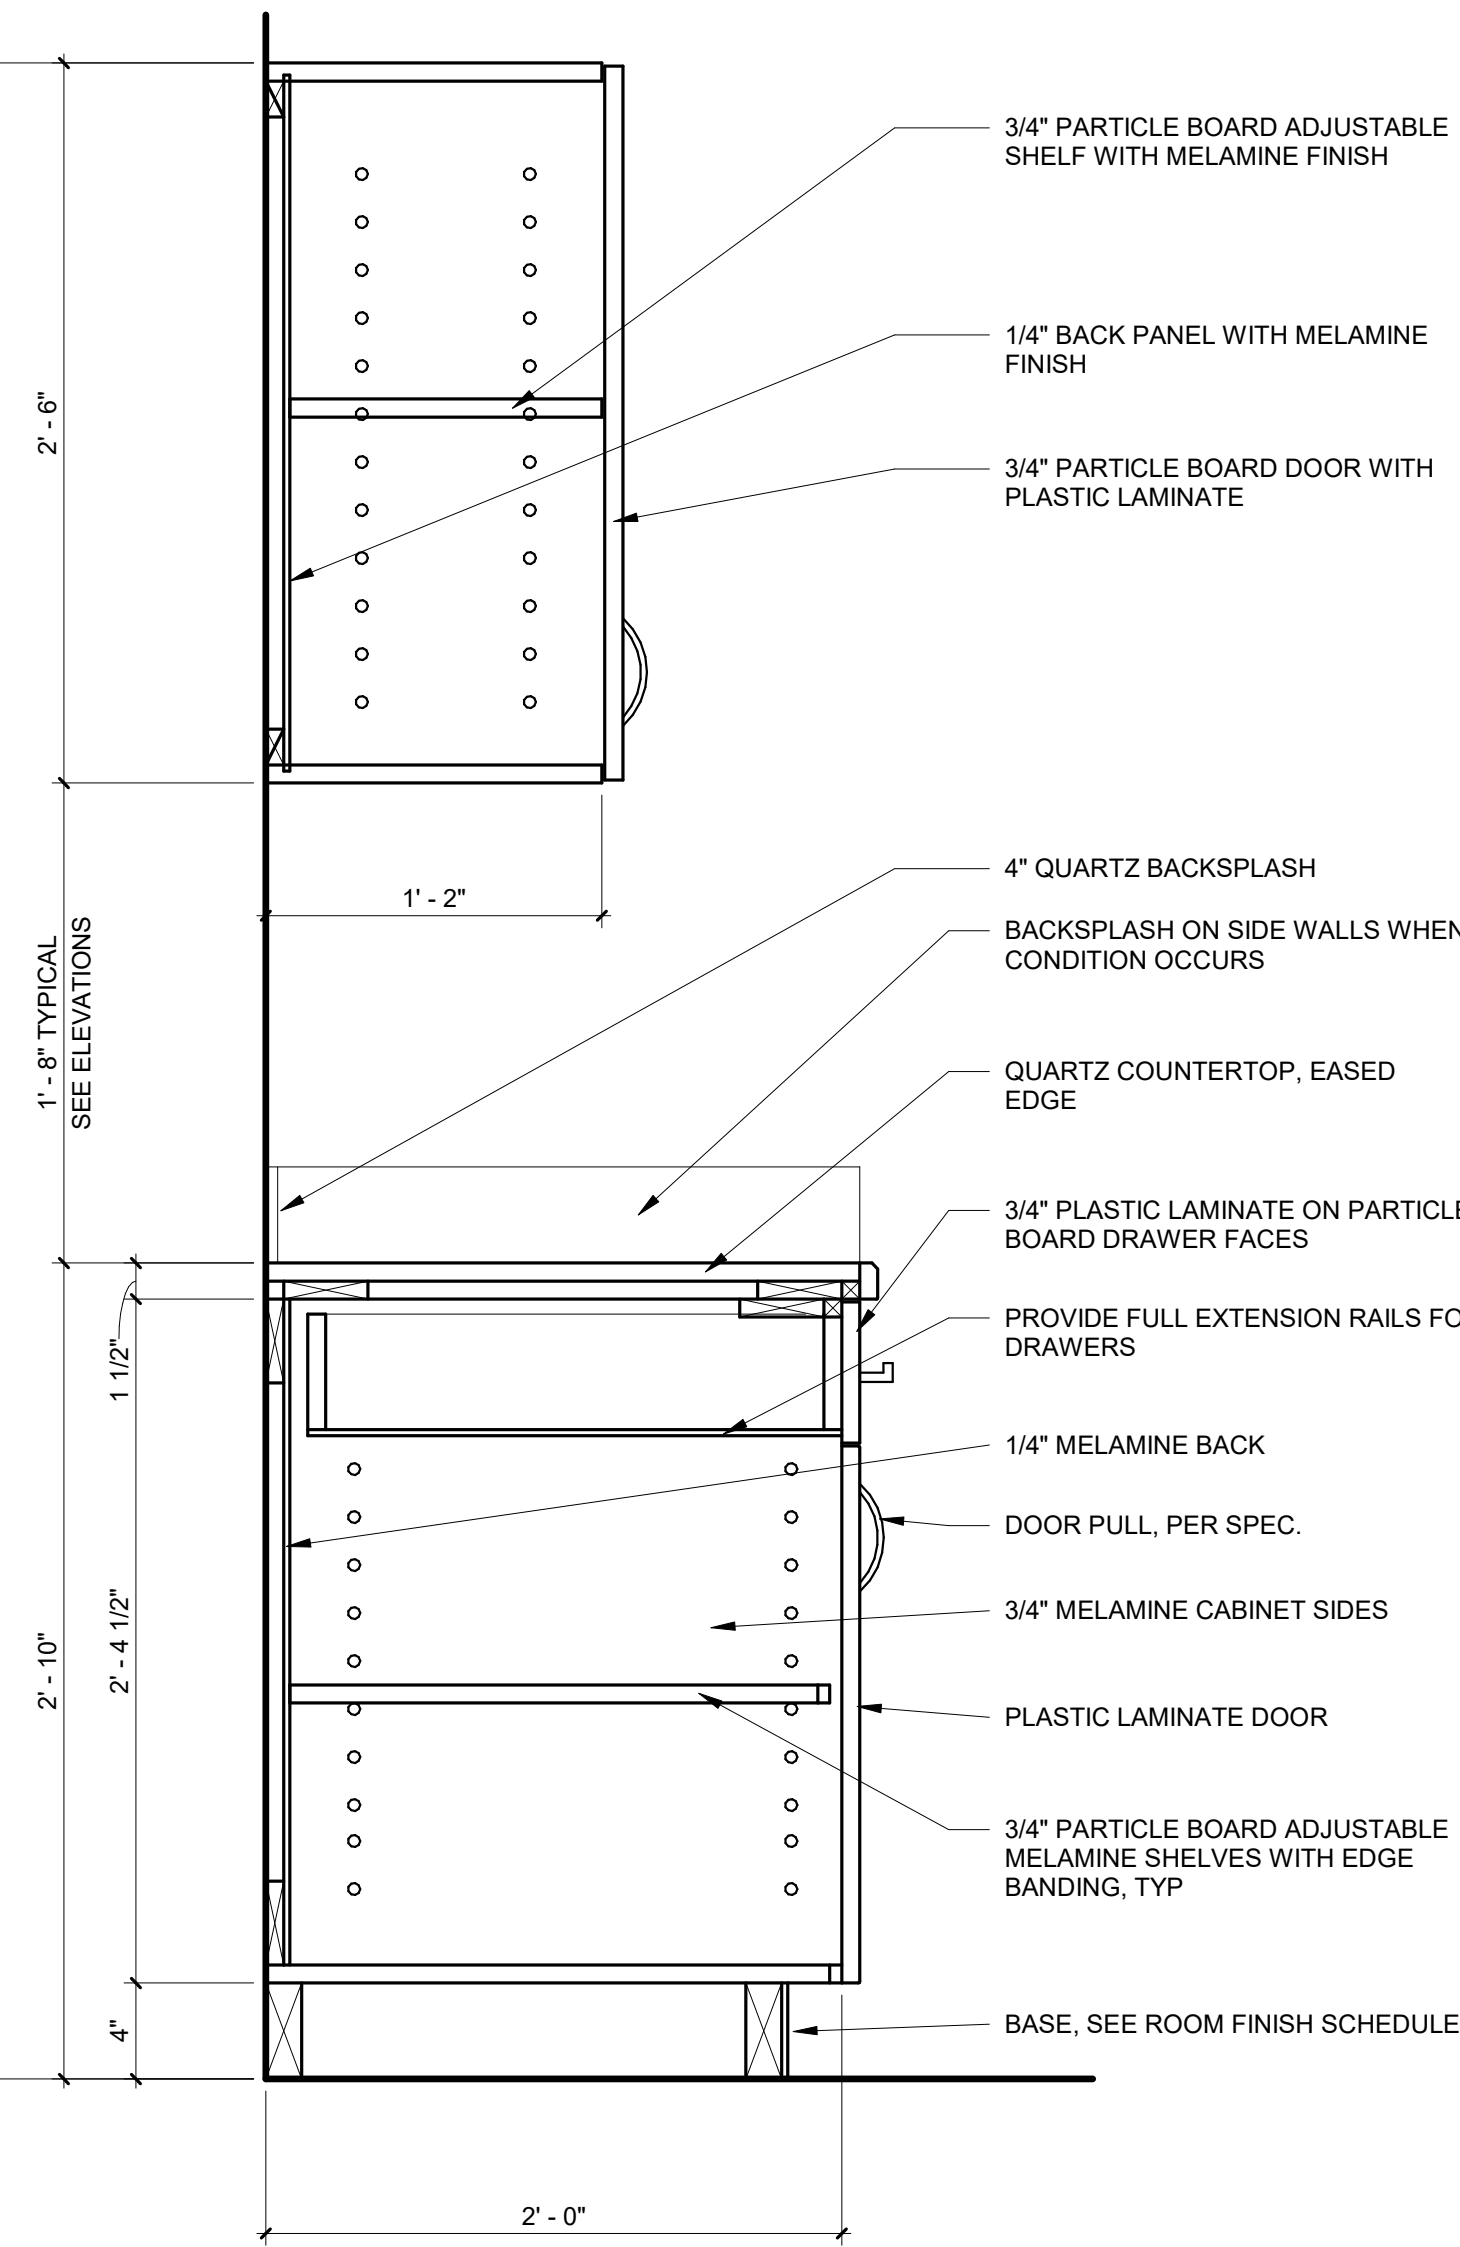

5 LOCKER SECTION
1 1/2\"/>

6 ADA LOCKER SECTION
1 1/2\"/>

COMPLIANCY REVIEW INCLUDED	
Revisions:	Date
	2/23/2024

CONSULTANTS:

TERRASITE DESIGN
1635 DEADWOOD AVENUE
RAPID CITY, SOUTH DAKOTA 57702
PH: (605) 791-1736

Albertson Engineering Inc.

ALBERTSON ENGINEERING, INC.
315 NORTH MAIN AVENUE, SUITE 200
SIOUX FALLS, SOUTH DAKOTA 57104
PH: (605) 274-0880

FARRIS ENGINEERING
OMAHA (BROCK) [BENET] COUNCIL BLUFFS
PH: (402) 330-5900



ARCHITECT

FOURFRONT DESIGN, INC.
517 7TH STREET
RAPID CITY, SOUTH DAKOTA
57701
PH: (605) 342-9470
FAX: (605) 342-2377
WWW.FOURFRONTDESIGN.COM

Drawing Title
ROOM FINISH SCHEDULE -
ALTERNATIVE BID #4

Approved: Project Director
Omaha VA Medical Center

Project Title
Design/Construct Sterile
Processing Service- Omaha VA
Medical Center

Location
4101 Woolworth Ave #4199
Omaha, Ne 68105

Project Number
16.2330.A08

Building Number
25

Drawing Number
A-500.1
Dwg. 65 of 193

Office of
Construction
and Facilities
Management



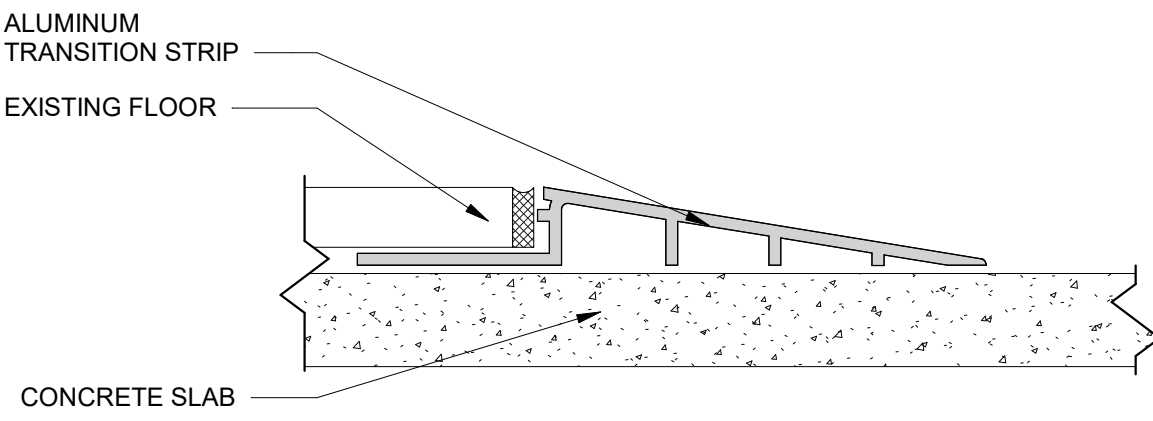
CONSTRUCTION DOCUMENTS

GENERAL NOTES:


1. SHEET SIZE FOR PROPER SCALE IS 30X42. CONTRACTOR SHALL NOT SCALE DRAWINGS BUT SHALL REQUEST THE DESIRED DIMENSIONS FROM THE ARCHITECT.
2. SEE SHEET G-002 FOR GENERAL NOTES.
3. APPLY 1 1/2" THICK FIREPROOFING AT ALL EXPOSED STEEL WITHIN INTERSTITIAL SPACE AND AT EXPOSED STEEL STRUCTURE ABOVE 3RD FLOOR CEILING, TYP.

FLOOR FINISH LEGEND:

- EPOXY COATED CONCRETE
- RF - RUBBER FLOORING
- LVT1 - LUXURY VINYL TILE
- RES-6 - RESINOUS FLOORING
- PT1 - PORCELAIN TILE
- PT3 - PORCELAIN TILE
- CPT-1 - CARPET TILE




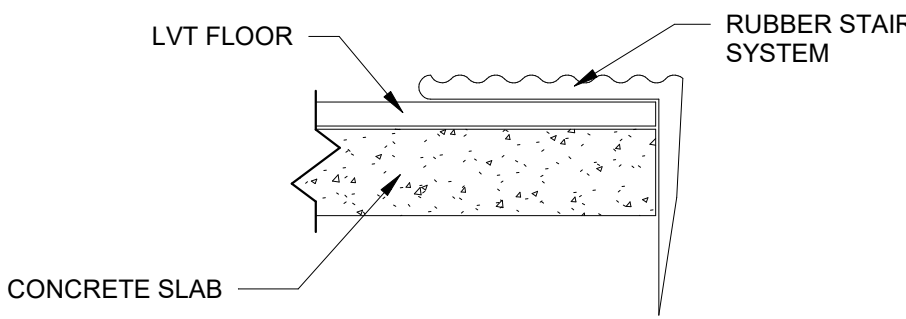2. TILE/LVT TO RESINOUS FLOORING
12" = 1'-0"



3. RUBBER STAIR SYSTEM TO LVT
12" = 1'-0"

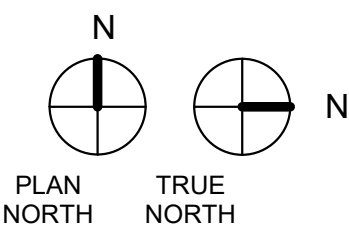1. FLOOR FINISH PLAN - 2ND LEVEL
1/8" = 1'-0"



CONSTRUCTION DOCUMENTS

7/27/2022 11:55:59 AM COMPLIANCY REVIEW INCLUDED Revisions:		CONSULTANTS:  TERRASITE DESIGN 1635 DEADWOOD AVENUE RAPID CITY, SOUTH DAKOTA 57702 PH: (605) 791-1736  Albertson Engineering Inc.  FARRIS ENGINEERING OMAHA (B-0004) SEWER COUNCIL BLUFFS farris-engineering.com PH: 1.828.643  ALBERTSON ENGINEERING, INC. 315 NORTH MAIN AVENUE, SUITE 200 SIOUX FALLS, SOUTH DAKOTA 57104 PH: (605) 274-0880  FARRIS ENGINEERING 12700 WEST DODGE ROAD OMAHA, NEBRASKA 68154 PH: (402) 330-5900		ARCHITECT  FOURFRONT DESIGN, INC. 517 7TH STREET RAPID CITY, SOUTH DAKOTA 57701 PH: (605) 342-9470 FAX: (605) 342-2377 WWW.FOURFRONTDESIGN.COM 		Drawing Title FLOOR FINISH PLAN - 2ND LEVEL Approved: Project Director Omaha VA Medical Center		Project Title Design/Construct Sterile Processing Service- Omaha VA Medical Center Location 4101 Woolworth Ave #4199 Omaha, Ne 68105 Date 11/23/2020 Checked JL Drawn JGC	Project Number 16.2330.A08 Building Number 25 Drawing Number A-510 Dwg. 66 of 193		Office of Construction and Facilities Management  Department of Veterans Affairs	
--	--	---	--	--	--	--	--	---	--	--	---	--

7/27/2022 11:55:53 AM

one eighth inch = one foot
one quarter inch = one foot
three eighths inch = one foot
one half inch = one foot
three quarters inch = one foot
one and one half inches = one foot
one and one half inches = one foot
one and one half inches = one foot

one eighth inch = one foot
one quarter inch = one foot
three eighths inch = one foot
one half inch = one foot
three quarters inch = one foot
one and one half inches = one foot
one and one half inches = one foot
one and one half inches = one foot

one eighth inch = one foot
one quarter inch = one foot
three eighths inch = one foot
one half inch = one foot
three quarters inch = one foot
one and one half inches = one foot
one and one half inches = one foot
one and one half inches = one foot

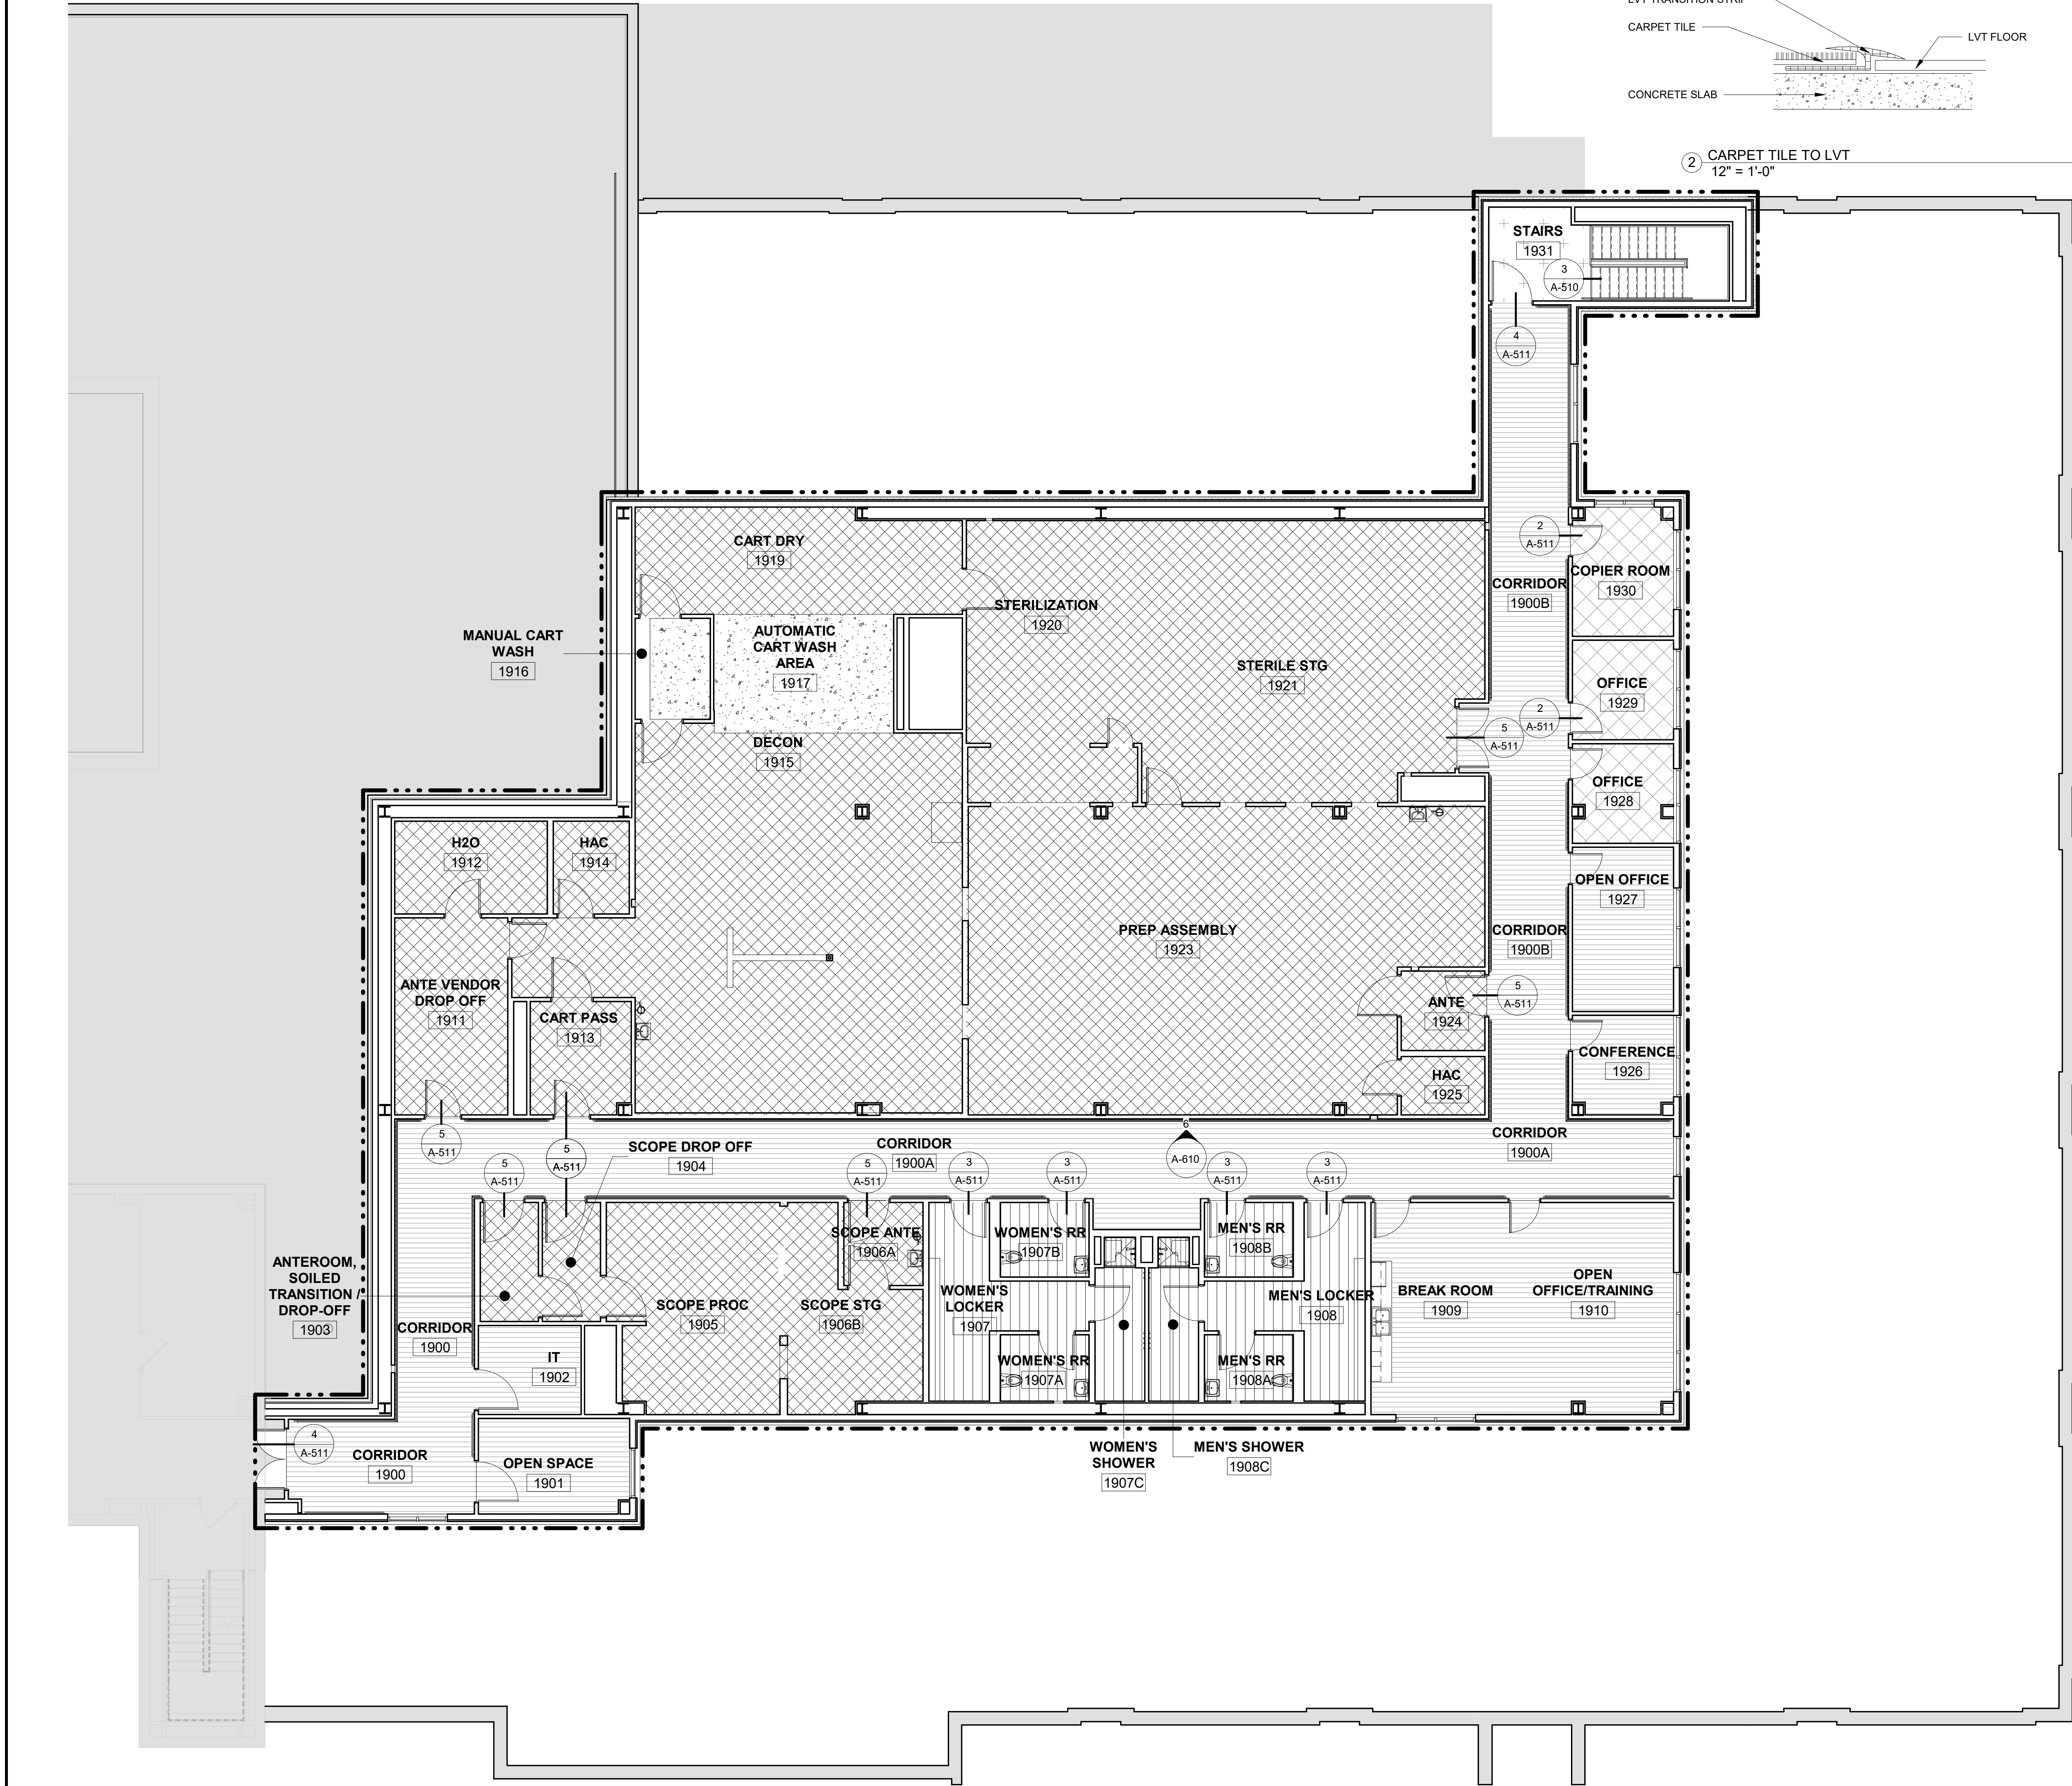
one eighth inch = one foot
one quarter inch = one foot
three eighths inch = one foot
one half inch = one foot
three quarters inch = one foot
one and one half inches = one foot
one and one half inches = one foot
one and one half inches = one foot

one eighth inch = one foot
one quarter inch = one foot
three eighths inch = one foot
one half inch = one foot
three quarters inch = one foot
one and one half inches = one foot
one and one half inches = one foot
one and one half inches = one foot



one eighth inch = one foot
one quarter inch = one foot
three eighths inch = one foot
one half inch = one foot
three quarters inch = one foot
one and one half inches = one foot
one and one half inches = one foot
one and one half inches = one foot

one eighth inch = one foot
one quarter inch = one foot
three eighths inch = one foot
one half inch = one foot
three quarters inch = one foot
one and one half inches = one foot
one and one half inches = one foot
one and one half inches = one foot


one eighth inch = one foot
one quarter inch = one foot
three eighths inch = one foot
one half inch = one foot
three quarters inch = one foot
one and one half inches = one foot
one and one half inches = one foot
one and one half inches = one foot



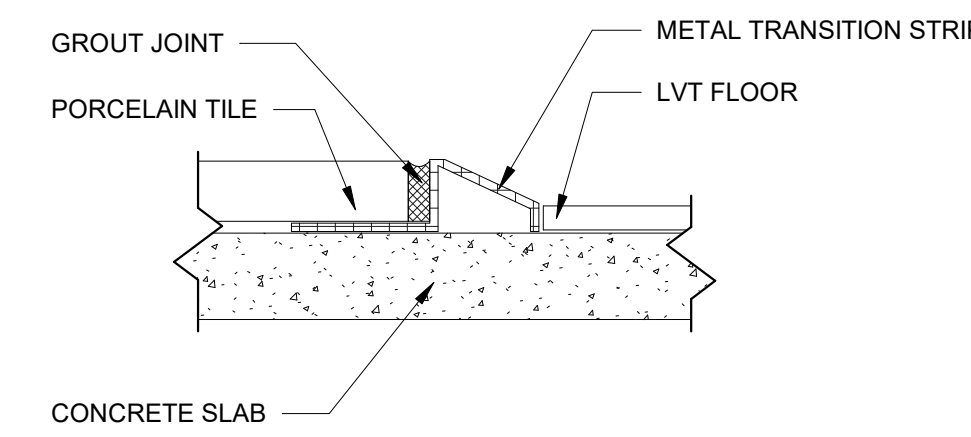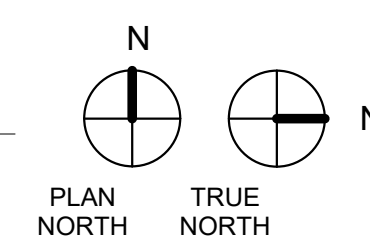
1 FLOOR FINISH PLAN - 3RD LEVEL
1/8" = 1'-0"




3 PORCELAIN TILE TO LVT
12" = 1'-0"

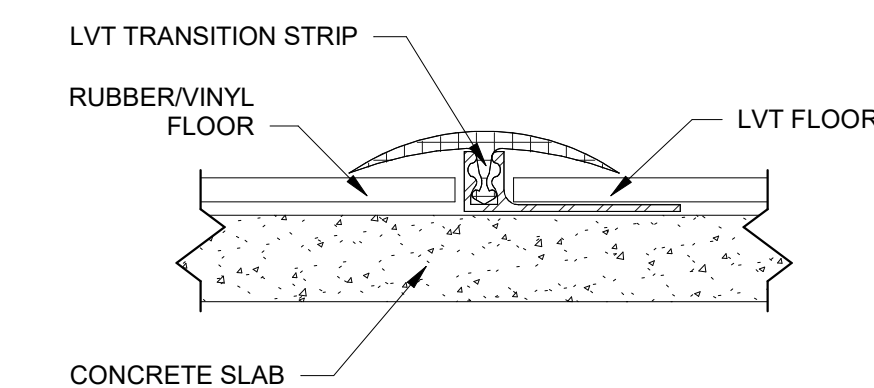


4 RUBBER FLOORING TO LVT
12" = 1'-0"

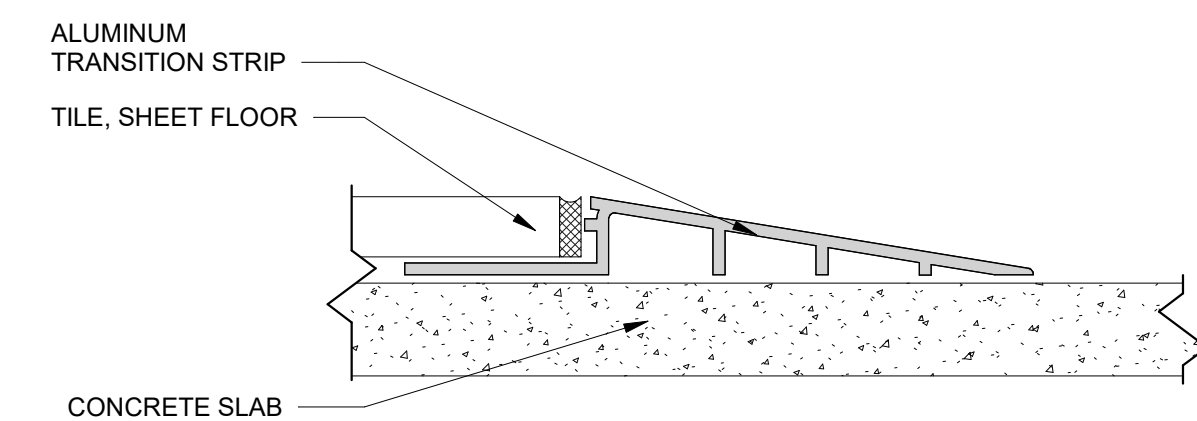

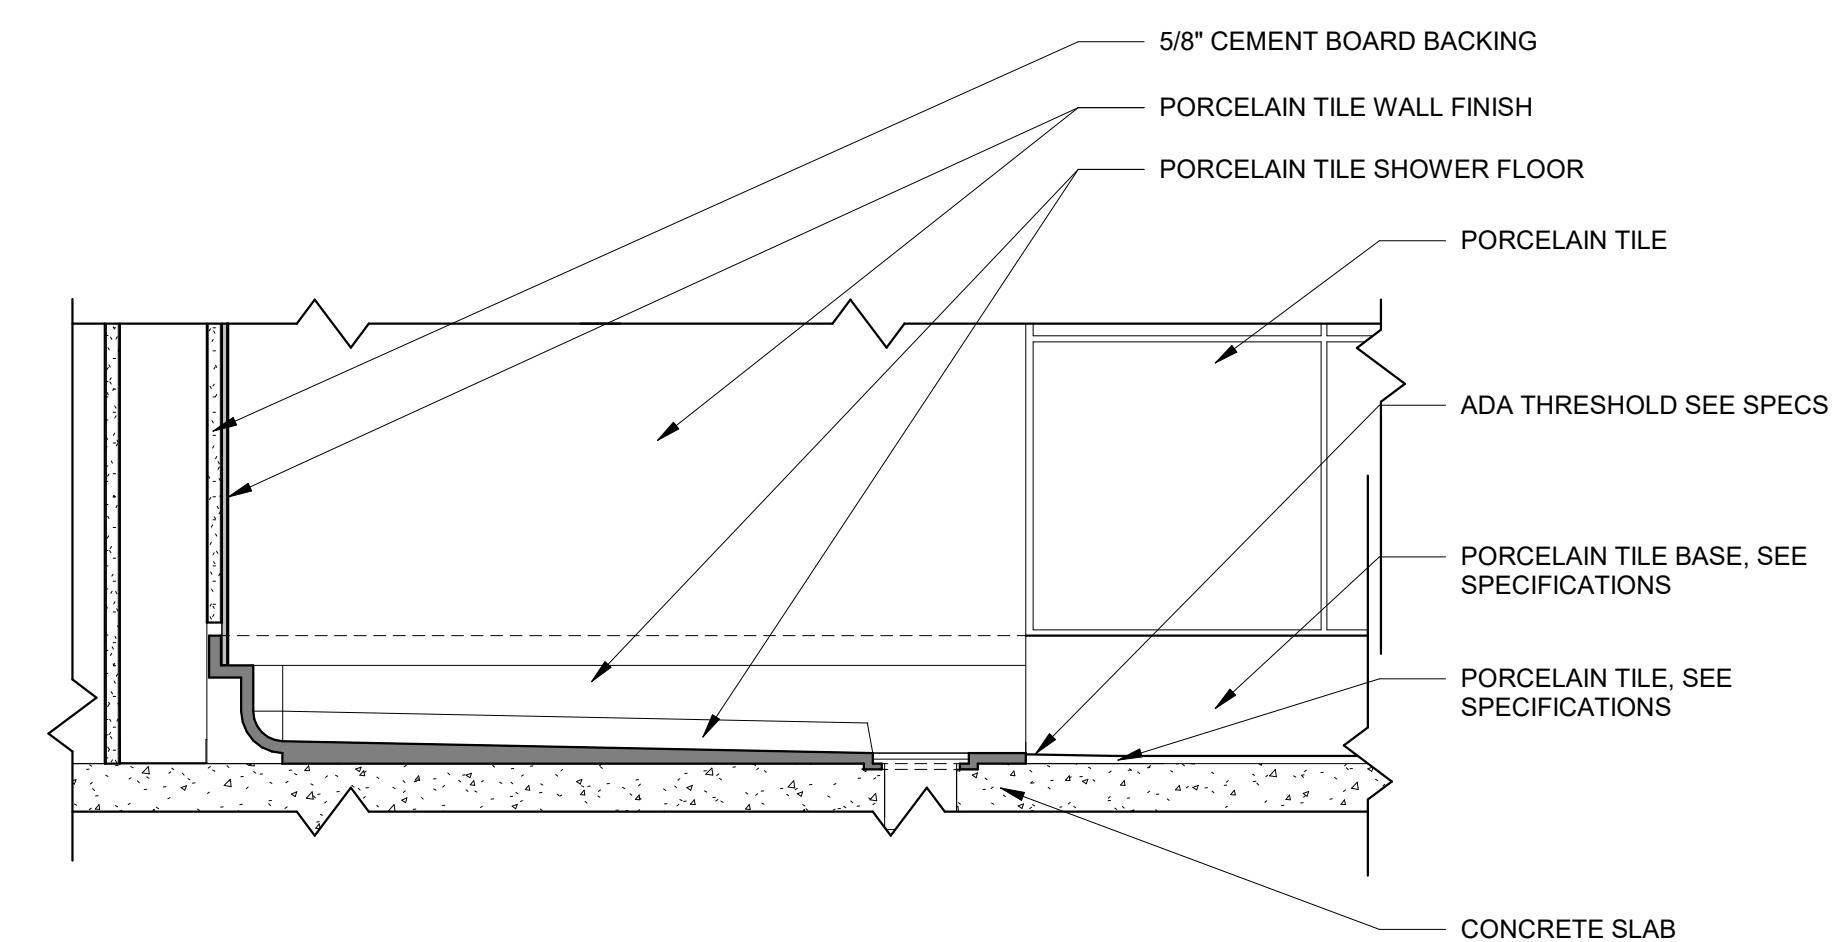
5 TILE/LVT TO RESINOUS FLOORING
12" = 1'-0"



6 SHOWER BASE DETAIL
1 1/2" = 1'-0"

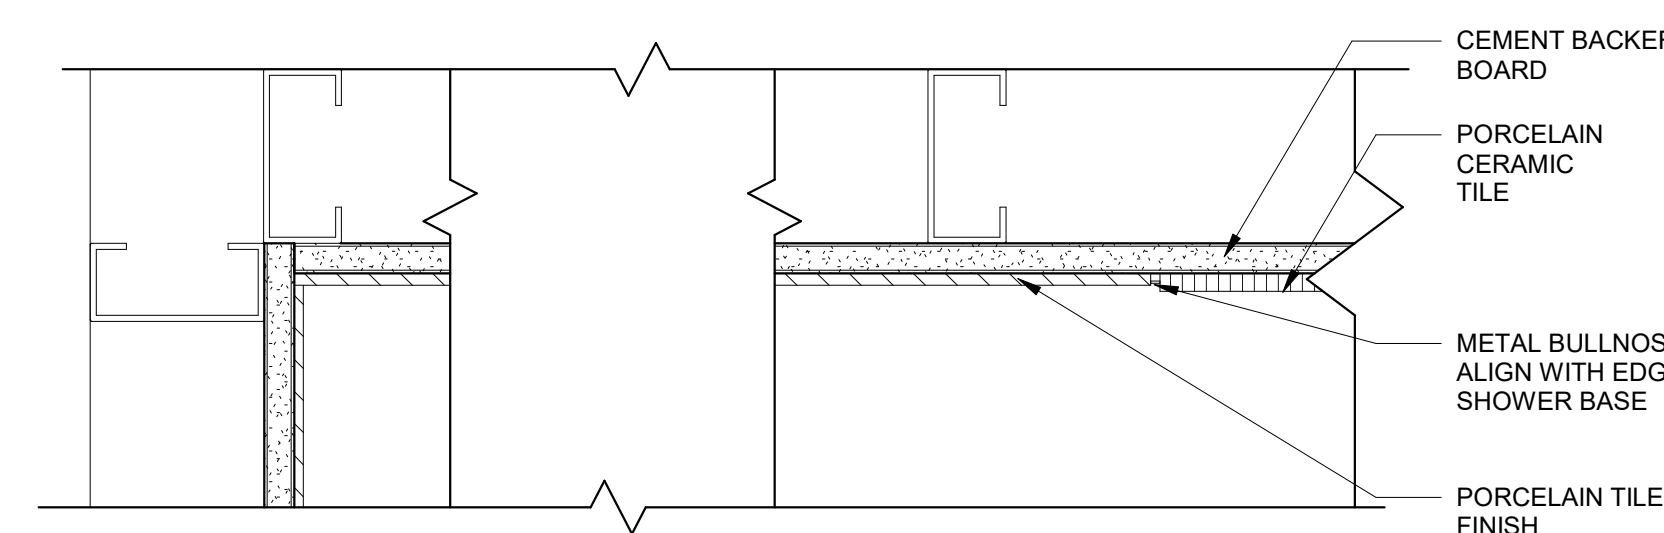

7 SHOWER STALL DETAILS
3" = 1'-0"

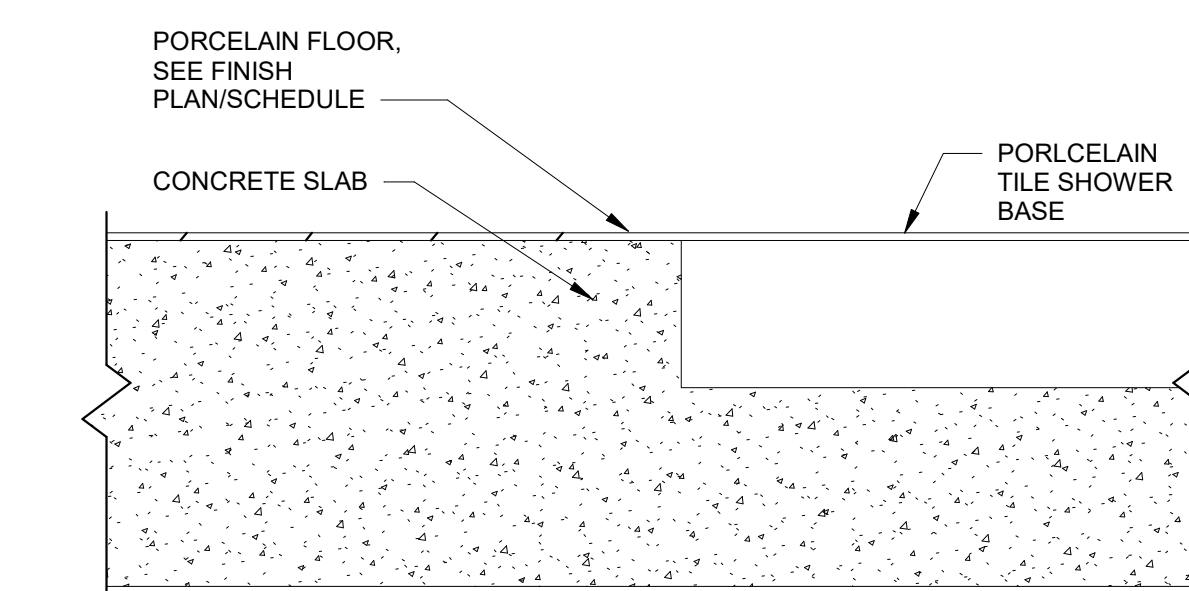

8 SHOWER RECEPTOR
6" = 1'-0"

GENERAL NOTES:

1. SHEET SIZE FOR PROPER SCALE IS 30X42. CONTRACTOR SHALL NOT SCALE DRAWINGS BUT SHALL REQUEST THE DESIRED DIMENSIONS FROM THE ARCHITECT.
2. SEE SHEET G-002 FOR GENERAL NOTES.
3. APPLY 1 1/2" THICK FIREPROOFING AT ALL EXPOSED STEEL WITHIN INTERSTITIAL SPACE AND AT EXPOSED STEEL STRUCTURE ABOVE 3RD FLOOR CEILING, TYP.

SHEET SPECIFIC NOTES:

1. SEE WALL PROTECTION PLAN FOR SPECIFIC LOCATIONS OF WALL PANELS, CORNER GUARDS, BUMPER RAILS AND HANDRAILS.
2. PORCELAIN TILE: SOLID SURFACING, RESINOUS WALL APPLICATION OVER CONCRETE BACKER BOARD. SEE SPECIFICATIONS.
3. COORDINATE SHOWER STALL AND FLOOR LAYOUTS BASED ON DIMENSIONS OF SHOWER FLOOR MANUFACTURER'S ROUGH-IN REQUIREMENTS.

FLOOR FINISH LEGEND:

- EPOXY COATED CONCRETE
- RF - RUBBER FLOORING
- LVT1 - LUXURY VINYL TILE
- RES-6 - RESINOUS FLOORING
- PT1 - PORCELAIN TILE
- PT3 - PORCELAIN TILE
- CPT-1 - CARPET TILE


CONSTRUCTION DOCUMENTS

COMPLIANCY REVIEW INCLUDED	2/23/2024
Revisions:	Date

CONSULTANTS:



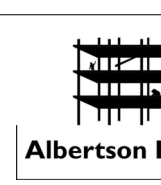TERRASITE DESIGN
1635 DEADWOOD AVENUE
RAPID CITY, SOUTH DAKOTA 57702
PH: (605) 791-1736



Albertson Engineering Inc.

ALBERTSON ENGINEERING, INC.
315 NORTH MAIN AVENUE, SUITE 200
SIOUX FALLS, SOUTH DAKOTA 57104
PH: (605) 274-0880

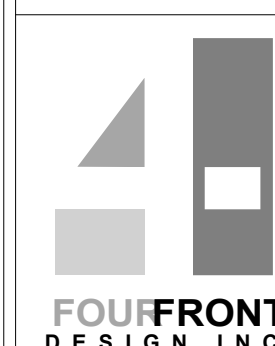


FARRIS ENGINEERING
OMAHA (BRANCH) 1001 F STREET
OMAHA, NEBRASKA 68102
PH: (402) 330-5900

FARRIS ENGINEERING
12700 WEST DODGE ROAD
OMAHA, NEBRASKA 68154
PH: (402) 330-5900



ARCHITECT



FOURFRONT DESIGN, INC.
517 7TH STREET
RAPID CITY, SOUTH DAKOTA
57701
PH: (605) 342-9470
FAX: (605) 342-2377
WWW.FOURFRONTDESIGN.COM

Drawing Title

FLOOR FINISH PLAN - 3RD LEVEL AND
FLOORING TRANSITION DETAILS

Approved: Project Director

Omaha VA Medical Center

Project Title

Design/Construct Sterile
Processing Service- Omaha VA
Medical Center

Location 4101 Woolworth Ave #4199
Omaha, Ne 68105

Date 11/23/2020

Checked JL

Drawn JGC

Project Number

16.2330.A08

Building Number

25

Drawing Number

A-511

Dwg. 67 of 193

Office of
Construction
and Facilities
Management



Department of
Veterans Affairs

5/18/2023 1:44:44 PM

one eighth inch = one foot
one quarter inch = one foot
three eighths inch = one foot
one half inch = one foot
three quarters inch = one foot
one and one half inches = one foot
one and one half inches = one foot

one eighth inch = one foot
one quarter inch = one foot
three eighths inch = one foot
one half inch = one foot
three quarters inch = one foot
one and one half inches = one foot
one and one half inches = one foot

one eighth inch = one foot
one quarter inch = one foot
three eighths inch = one foot
one half inch = one foot
three quarters inch = one foot
one and one half inches = one foot
one and one half inches = one foot

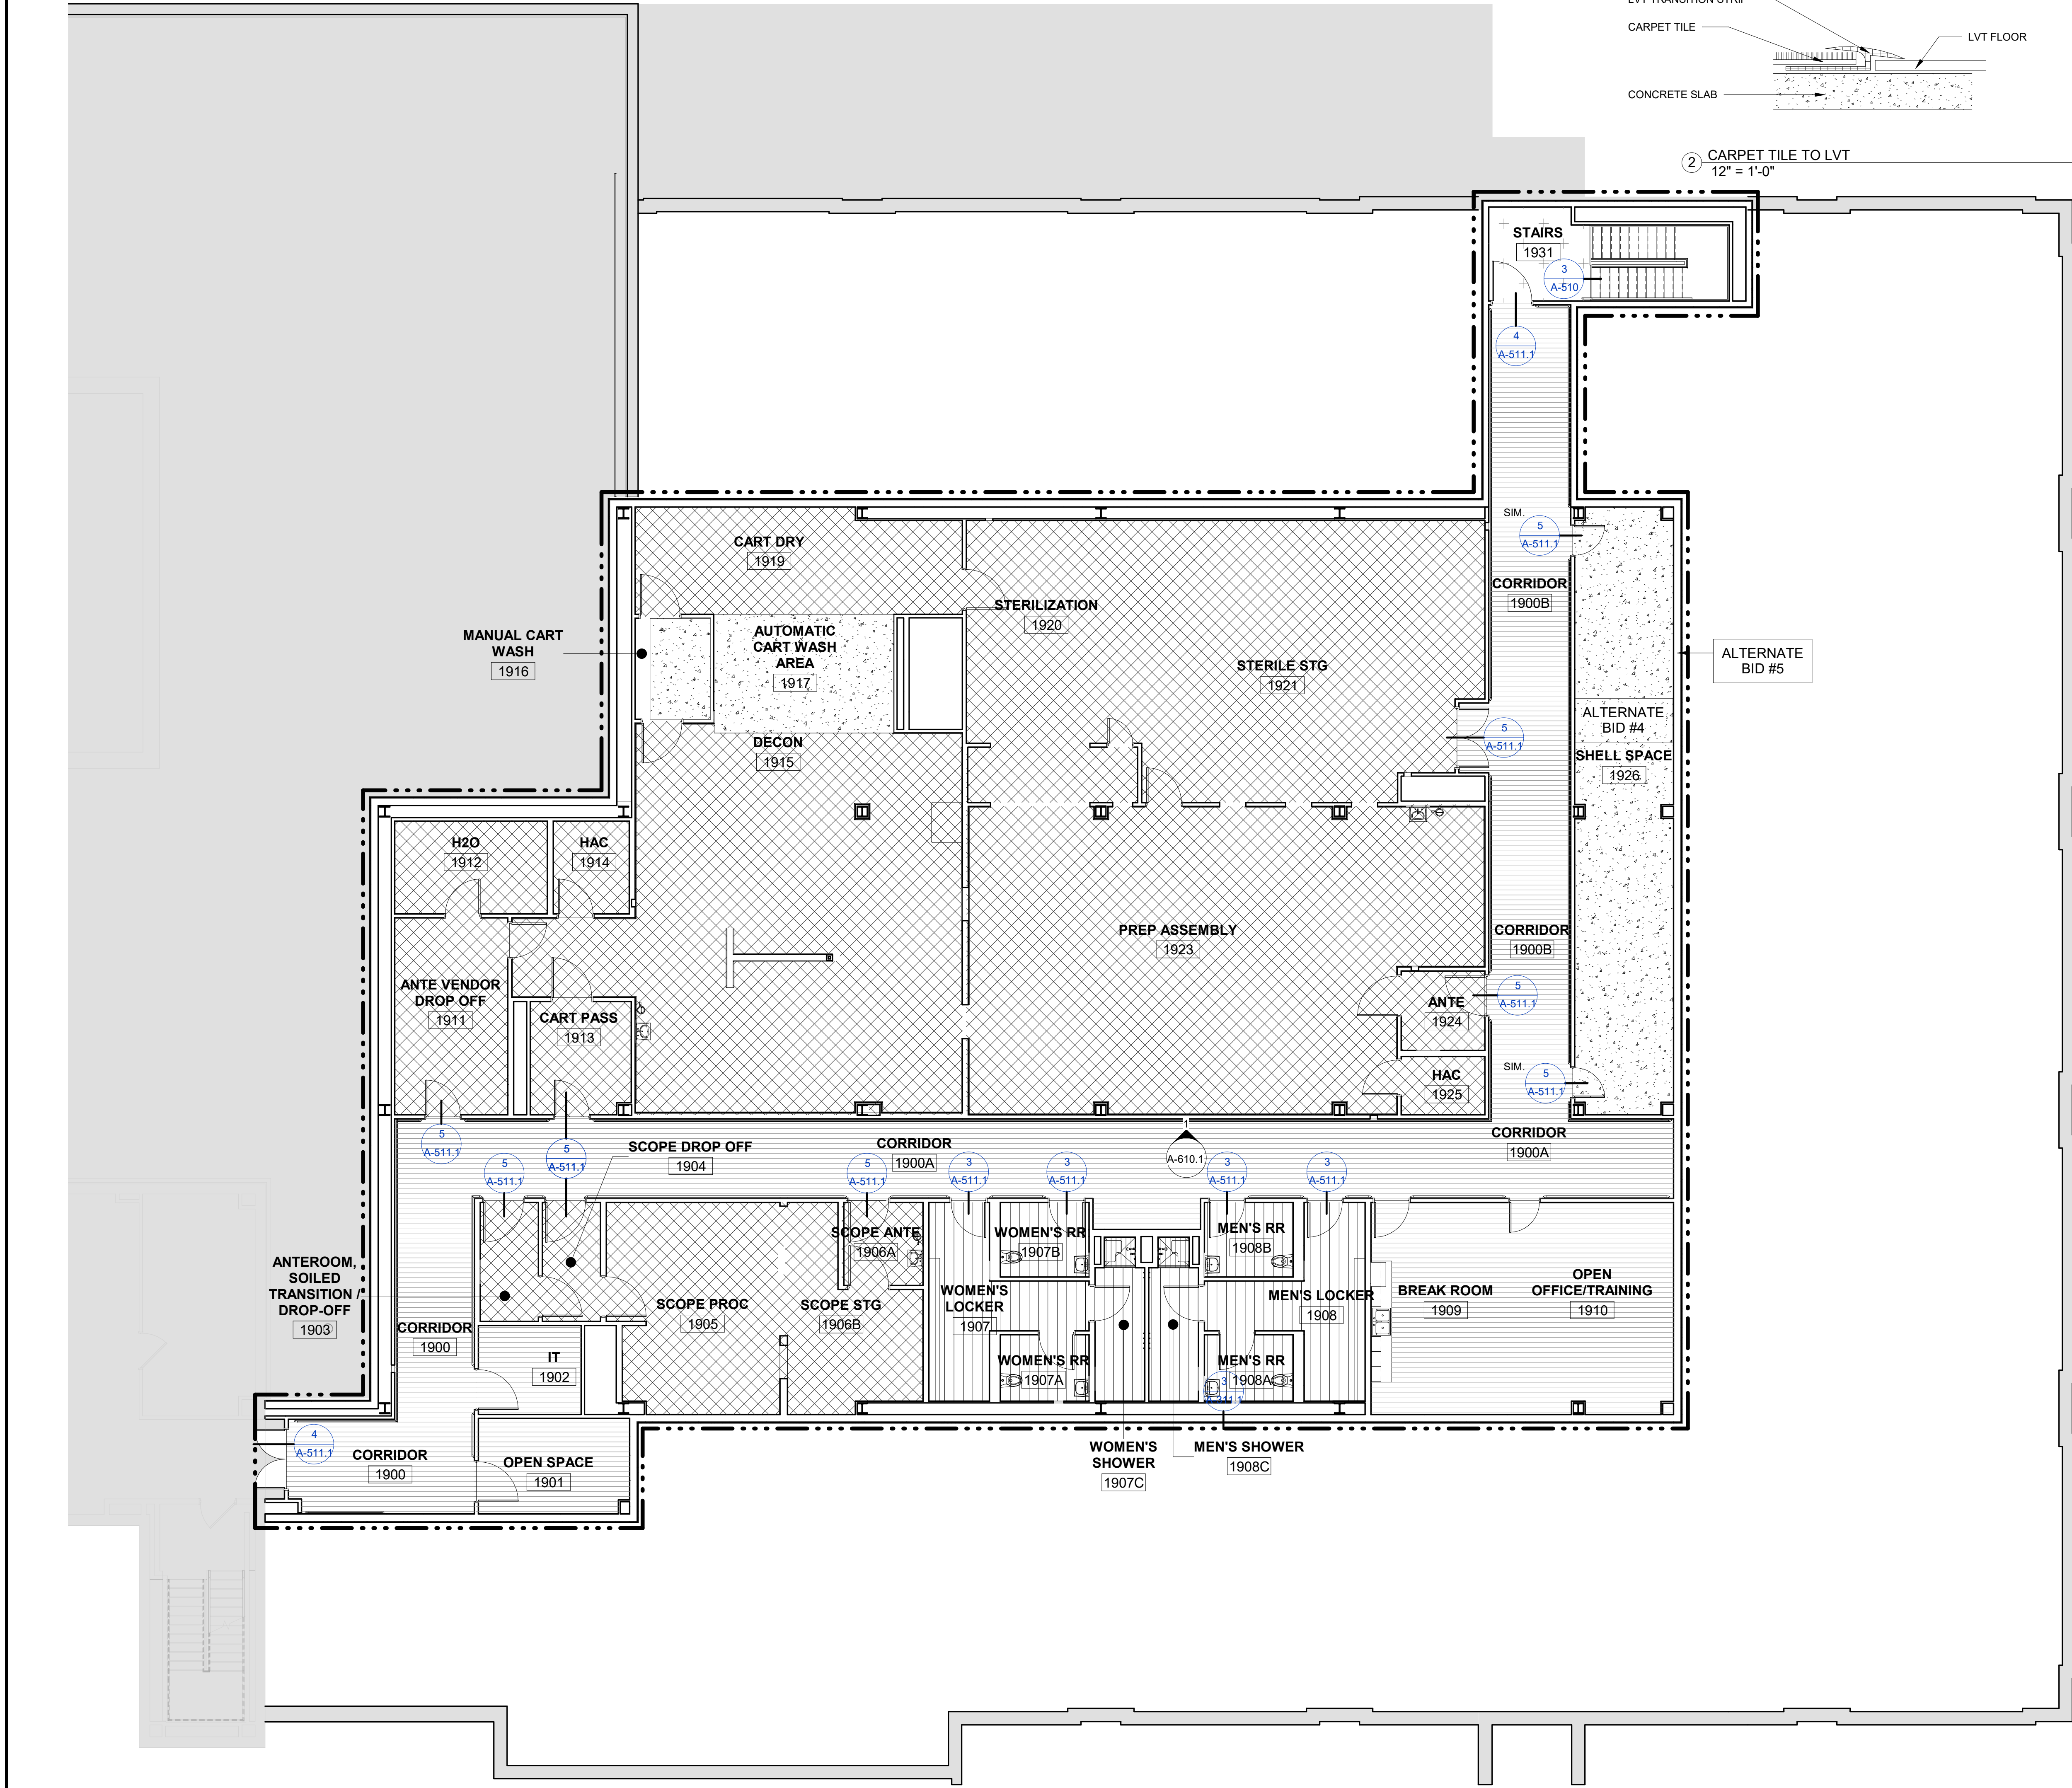
one eighth inch = one foot
one quarter inch = one foot
three eighths inch = one foot
one half inch = one foot
three quarters inch = one foot
one and one half inches = one foot
one and one half inches = one foot

one eighth inch = one foot
one quarter inch = one foot
three eighths inch = one foot
one half inch = one foot
three quarters inch = one foot
one and one half inches = one foot
one and one half inches = one foot



one eighth inch = one foot
one quarter inch = one foot
three eighths inch = one foot
one half inch = one foot
three quarters inch = one foot
one and one half inches = one foot
one and one half inches = one foot

one eighth inch = one foot
one quarter inch = one foot
three eighths inch = one foot
one half inch = one foot
three quarters inch = one foot
one and one half inches = one foot
one and one half inches = one foot


one eighth inch = one foot
one quarter inch = one foot
three eighths inch = one foot
one half inch = one foot
three quarters inch = one foot
one and one half inches = one foot
one and one half inches = one foot



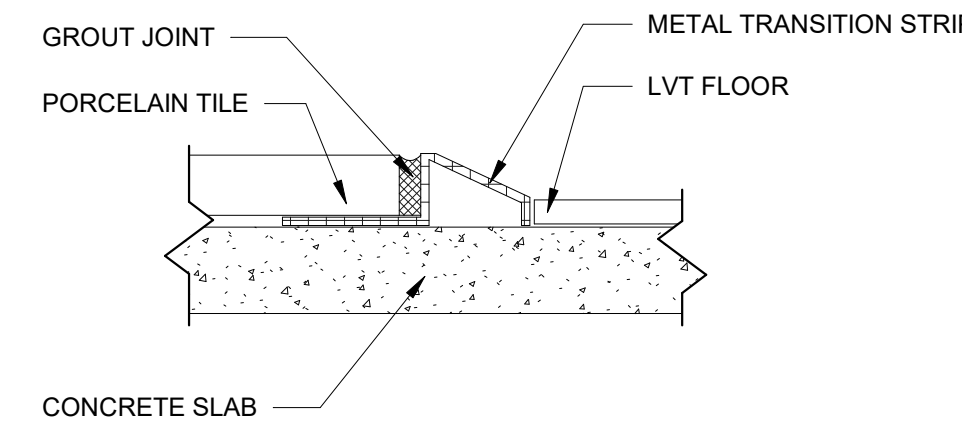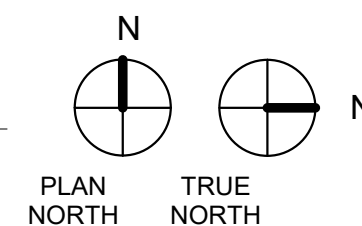
1 FLOOR FINISH PLAN - 3RD LEVEL
1/8" = 1'-0"




3 PORCELAIN TILE TO LVT
12" = 1'-0"

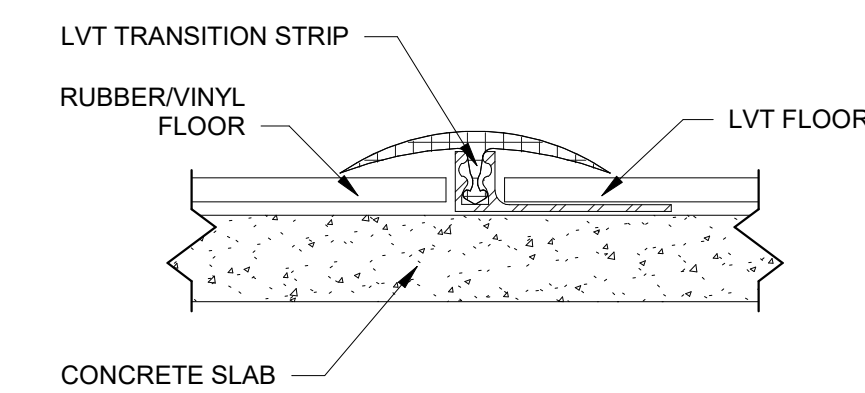


4 RUBBER FLOORING TO LVT
12" = 1'-0"

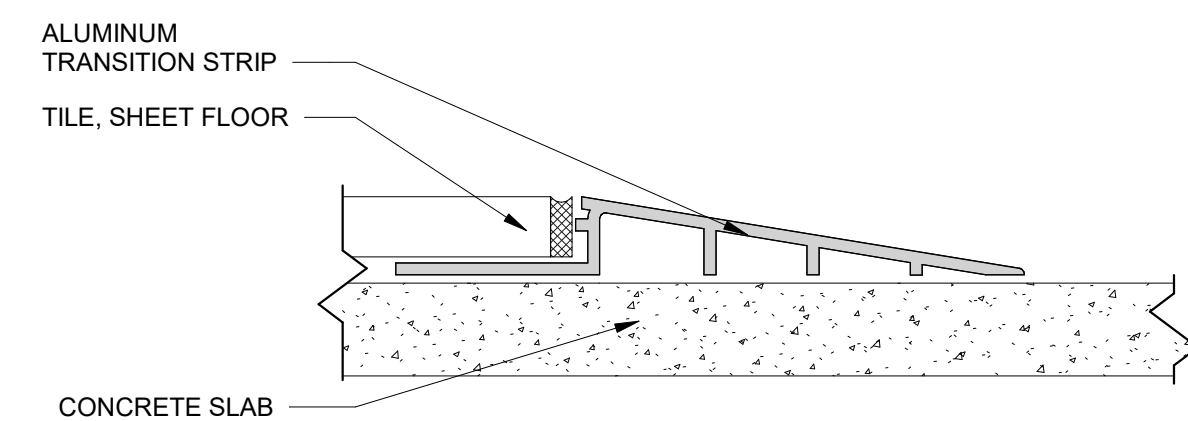

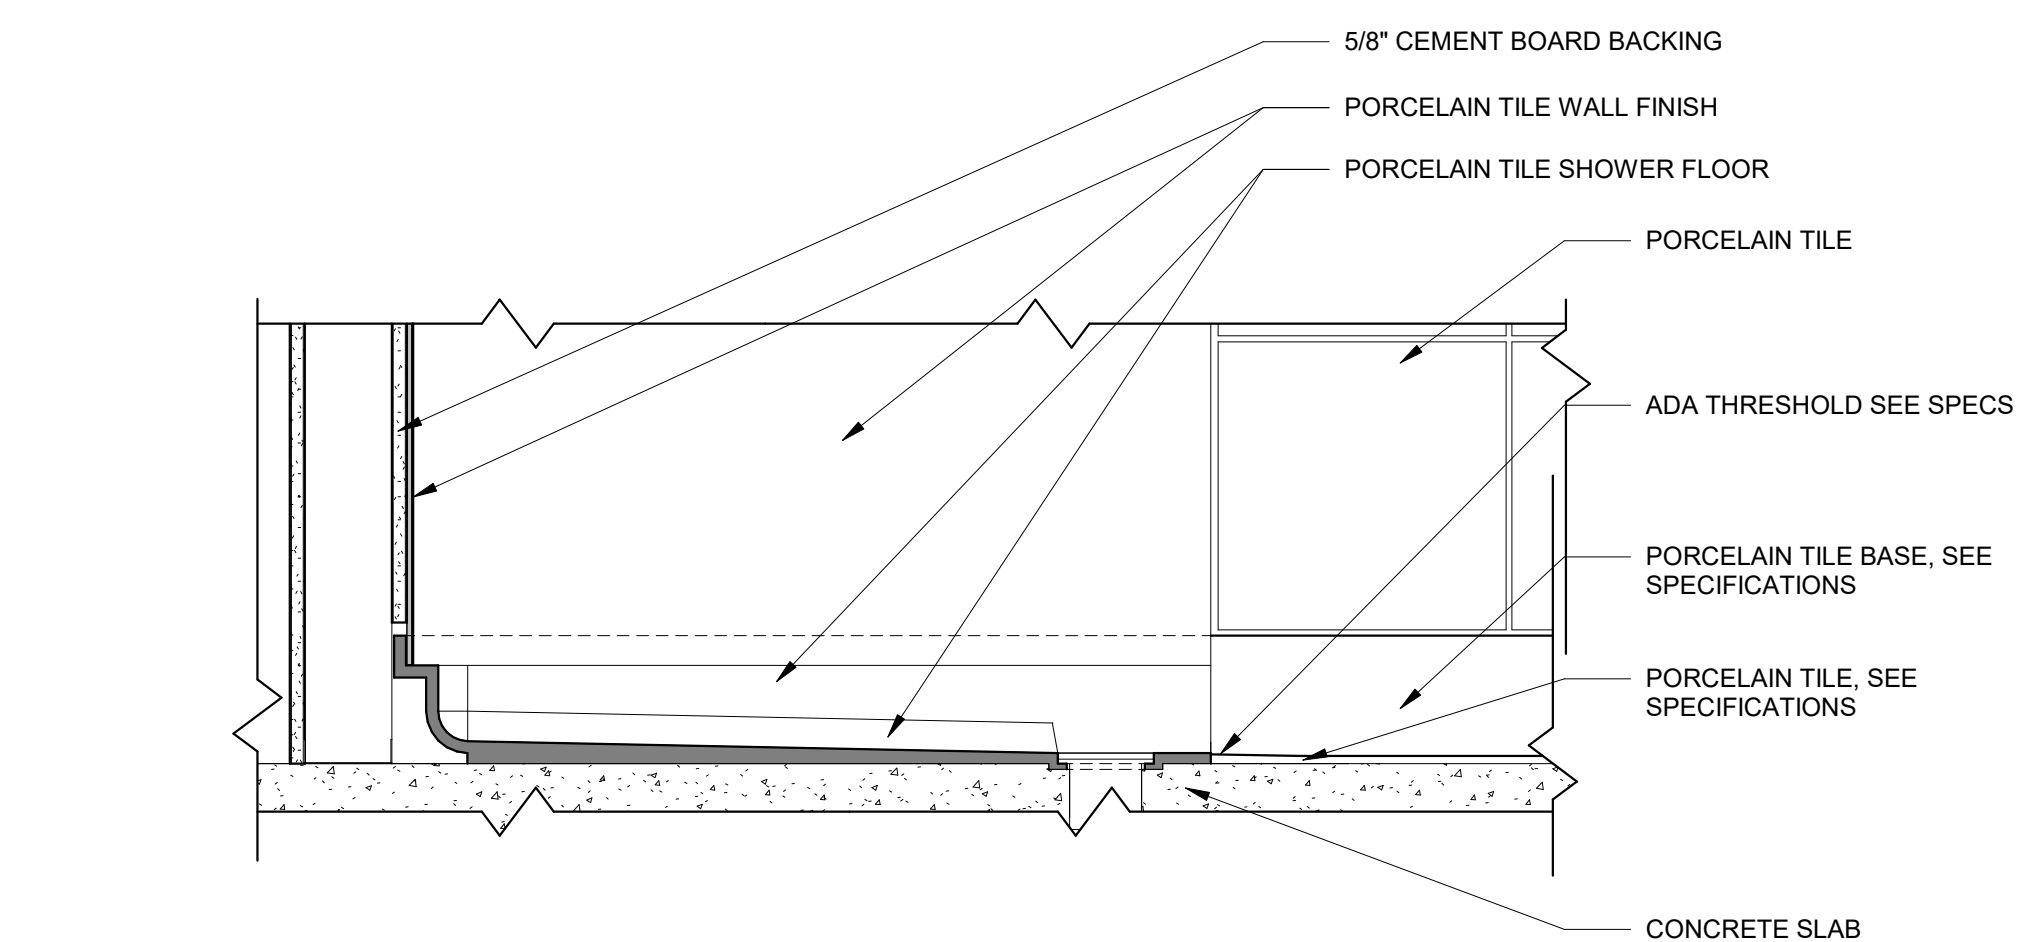
5 TILE/LVT TO RESINOUS FLOORING
12" = 1'-0"



6 SHOWER BASE DETAIL
1 1/2" = 1'-0"

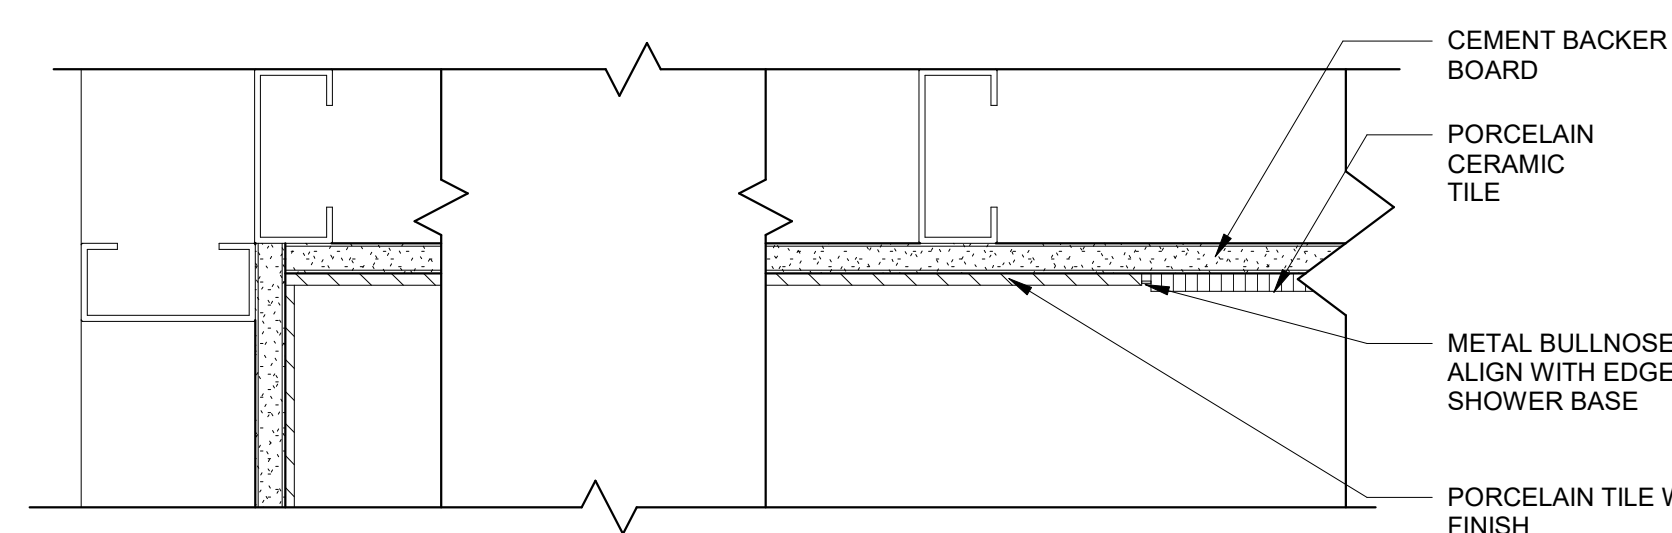

7 SHOWER STALL DETAILS
3" = 1'-0"

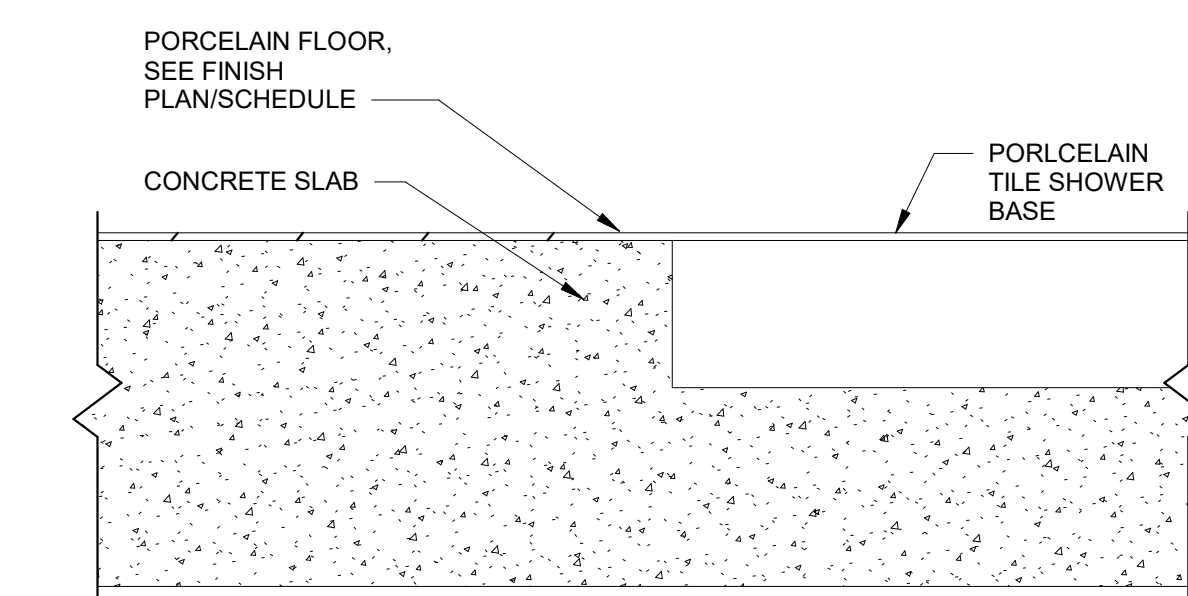

8 SHOWER RECEPTOR
6" = 1'-0"

GENERAL NOTES:

1. SHEET SIZE FOR PROPER SCALE IS 30X42. CONTRACTOR SHALL NOT SCALE DRAWINGS BUT SHALL REQUEST THE DESIRED DIMENSIONS FROM THE ARCHITECT.
2. SEE SHEET G-002 FOR GENERAL NOTES.
3. APPLY 1 1/2" THICK FIREPROOFING AT ALL EXPOSED STEEL WITHIN INTERSTITIAL SPACE AND AT EXPOSED STEEL STRUCTURE ABOVE 3RD FLOOR CEILING, TYP.

SHEET SPECIFIC NOTES:

1. SEE WALL PROTECTION PLAN FOR SPECIFIC LOCATIONS OF WALL PANELS, CORNER GUARDS, BUMPER RAILS AND HANDRAILS.
2. PORCELAIN TILE: SOLID SURFACING, RESINOUS WALL APPLICATION OVER CONCRETE BACKER BOARD. SEE SPECIFICATIONS.
3. COORDINATE SHOWER STALL AND FLOOR LAYOUTS BASED ON DIMENSIONS OF SHOWER FLOOR MANUFACTURER'S ROUGH-IN REQUIREMENTS.

FLOOR FINISH LEGEND:

- EPOXY COATED CONCRETE
- RF - RUBBER FLOORING
- LVT1 - LUXURY VINYL TILE
- RES-6 - RESINOUS FLOORING
- PT1 - PORCELAIN TILE
- PT3 - PORCELAIN TILE
- CPT-1 - CARPET TILE

CONSTRUCTION DOCUMENTS

COMPLIANCY REVIEW INCLUDED	2/23/2024
Revisions:	Date

CONSULTANTS:



TERRASITE DESIGN
1635 DEADWOOD AVENUE
RAPID CITY, SOUTH DAKOTA 57702
PH: (605) 791-1736



Albertson Engineering Inc.

ALBERTSON ENGINEERING, INC.
315 NORTH MAIN AVENUE, SUITE 200
SIOUX FALLS, SOUTH DAKOTA 57104
PH: (605) 274-0880

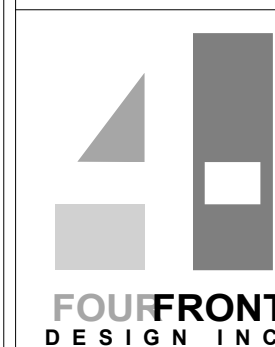


FARRIS ENGINEERING
OMAHA (BRANCH) (901) 440-0000
FARRIS-182263

FARRIS ENGINEERING
12700 WEST DODGE ROAD
OMAHA, NEBRASKA 68154
PH: (402) 330-5900



ARCHITECT



FOURFRONT DESIGN, INC.
517 7TH STREET
RAPID CITY, SOUTH DAKOTA
57701
PH: (605) 342-9470
FAX: (605) 342-2377
WWW.FOURFRONTDESIGN.COM

Drawing Title
FLOOR FINISH PLAN - 3RD LEVEL AND
FLOORING TRANSITION DETAILS -
ALTERNATIVE BID #4

Approved: Project Director
Omaha VA Medical Center

Project Title
Design/Construct Sterile
Processing Service- Omaha VA
Medical Center

Location 4101 Woolworth Ave #4199
Omaha, Ne 68105

Date
11/23/2020

Checked
JL

Drawn
JGC

 
Project Number
16.2330.A08

Building Number
25

Drawing Number
A-511.1

Dwg. 68 of 193

Office of
Construction
and Facilities
Management



GENERAL NOTES:

1. SHEET SIZE FOR PROPER SCALE IS 30X42. CONTRACTOR SHALL NOT SCALE DRAWINGS BUT SHALL REQUEST THE DESIRED DIMENSIONS FROM THE ARCHITECT.
2. SEE SHEET G-002 FOR GENERAL NOTES.
3. APPLY 1 1/2" THICK FIREPROOFING AT ALL EXPOSED STEEL WITHIN INTERSTITIAL SPACE AND AT EXPOSED STEEL STRUCTURE ABOVE 3RD FLOOR CEILING, TYP.

SHEET SPECIFIC NOTES:

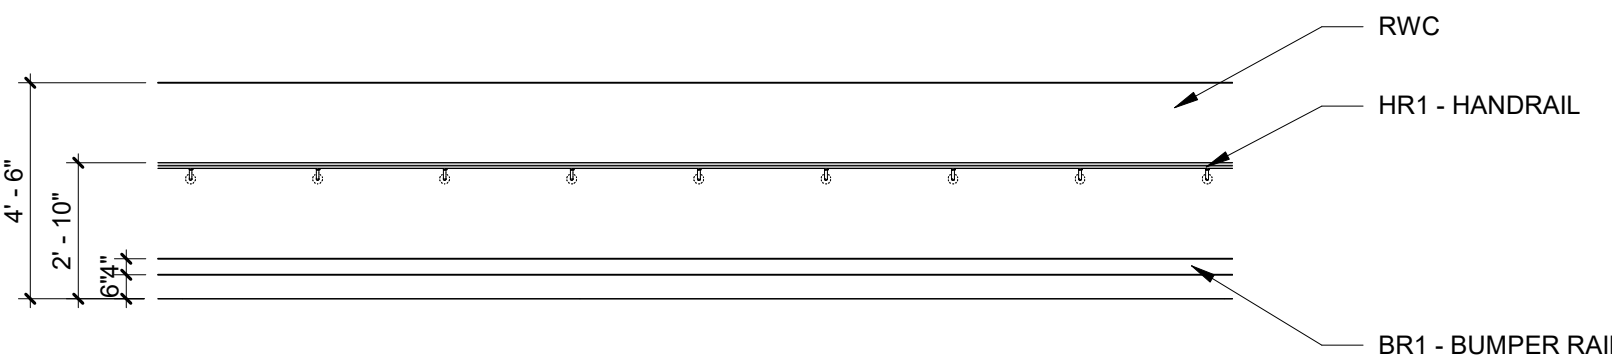
1. SEE INTERIOR ELEVATIONS FOR ADDITIONAL DETAILS AND WALL PROTECTION.
2. WHERE WALL PROTECTION WRAPS COLUMNS, PROVIDE COORDINATING CORNER GUARDS AND TRIM FOR A SEAMLESS INSTALLATION.

KEYNOTES:


- 10-21.1 CG-1, VINYL CORNER GUARD, SEE SPECIFICATION.
10-21.2 CG-2, STAINLESS STEEL CORNER GUARD, SEE SPECIFICATION.

WALL PROTECTION LEGEND:

- BUMPER/CRASHRAIL
--- HANDRAIL WITH GUARD
--- RWC: RIGID WALL PROTECTION PANEL 48" ABOVE BASE FINISH (1/4" OVERLAP)
--- TILE PT2 WAINSCOT FULL HT
--- TILE PT2 WAINSCOT 6'-0" AFF
--- RWC: RIGID WALL PANEL AT 8' - 0" ABOVE BASE FINISH




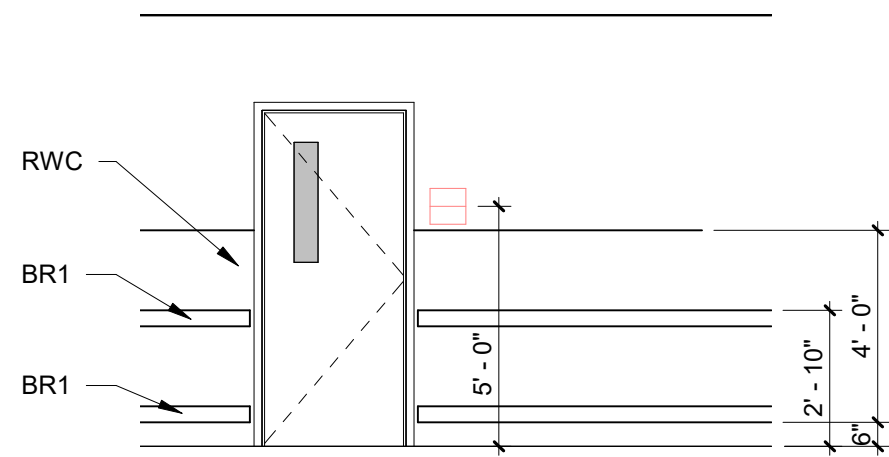2 CORRIDOR - TYPICAL WALL PROTECTION (AT HANDRAIL)
1/4" = 1'-0"



3 CORRIDOR - WALL PROTECTION (NON-HANDRAIL)
1/4" = 1'-0"

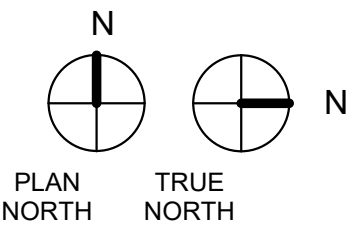1 WALL PROTECTION PLAN - 3RD LEVEL
1/8" = 1'-0"



COMPLIANCY REVIEW INCLUDED		2/23/2024		Date	
Revisions:		Date		Date	
CONSULTANTS:					
 TERRASITE DESIGN 1635 DEADWOOD AVENUE RAPID CITY, SOUTH DAKOTA 57702 PH: (605) 791-1736		 ALBERTSON ENGINEERING, INC. 315 NORTH MAIN AVENUE, SUITE 200 SIOUX FALLS, SOUTH DAKOTA 57104 PH: (605) 274-0880		 FARRIS ENGINEERING 12700 WEST DODGE ROAD OMAHA, NEBRASKA 68154 PH: (402) 330-5900	
ARCHITECT					
 FOURFRONT DESIGN, INC. 517 7TH STREET RAPID CITY, SOUTH DAKOTA 57701 PH: (605) 342-9470 FAX: (605) 342-2377 WWW.FOURFRONTDESIGN.COM					
Drawing Title		Project Number		Project Title	
WALL PROTECTION PLANS		16.2330.A08		Design/Construct Sterile Processing Service- Omaha VA Medical Center	
Approved: Project Director		Building Number		Location	
Omaha VA Medical Center		25		4101 Woolworth Ave #4199 Omaha, Ne 68105	
Date		Checked		Drawn	
11/23/2020		JL		JGC	
Dwg. 69 of 193		A-512		Office of Construction and Facilities Management	
					

GENERAL NOTES:

1. SHEET SIZE FOR PROPER SCALE IS 30X42. CONTRACTOR SHALL NOT SCALE DRAWINGS BUT SHALL REQUEST THE DESIRED DIMENSIONS FROM THE ARCHITECT.
2. SEE SHEET G-002 FOR GENERAL NOTES.
3. APPLY 1 1/2" THICK FIREPROOFING AT ALL EXPOSED STEEL WITHIN INTERSTITIAL SPACE AND AT EXPOSED STEEL STRUCTURE ABOVE 3RD FLOOR CEILING, TYP.

SHEET SPECIFIC NOTES:

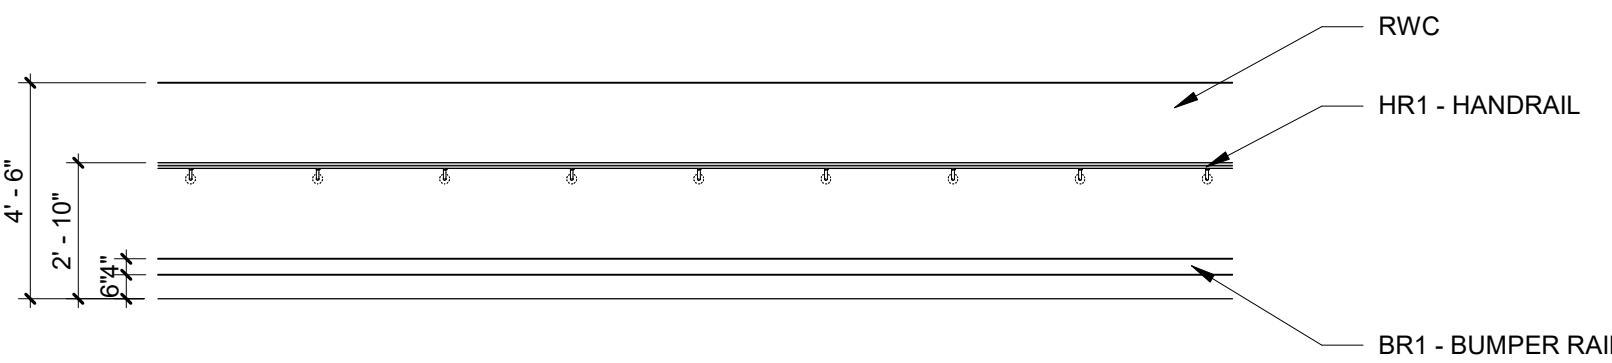
1. SEE INTERIOR ELEVATIONS FOR ADDITIONAL DETAILS AND WALL PROTECTION.
2. WHERE WALL PROTECTION WRAPS COLUMNS, PROVIDE COORDINATING CORNER GUARDS AND TRIM FOR A SEAMLESS INSTALLATION.

KEYNOTES:


- 10-21.1 CG-1, VINYL CORNER GUARD, SEE SPECIFICATION.
10-21.2 CG-2, STAINLESS STEEL CORNER GUARD, SEE SPECIFICATION.

WALL PROTECTION LEGEND:

- BUMPER/CRASHRAIL
--- HANDRAIL WITH GUARD
--- RWC: RIGID WALL PROTECTION PANEL 48" ABOVE BASE FINISH (1/4" OVERLAP)
--- TILE PT2 WAINSCOT FULL HT
--- TILE PT2 WAINSCOT 6'-0" AFF
--- RWC: RIGID WALL PANEL AT 8'-0" ABOVE BASE FINISH




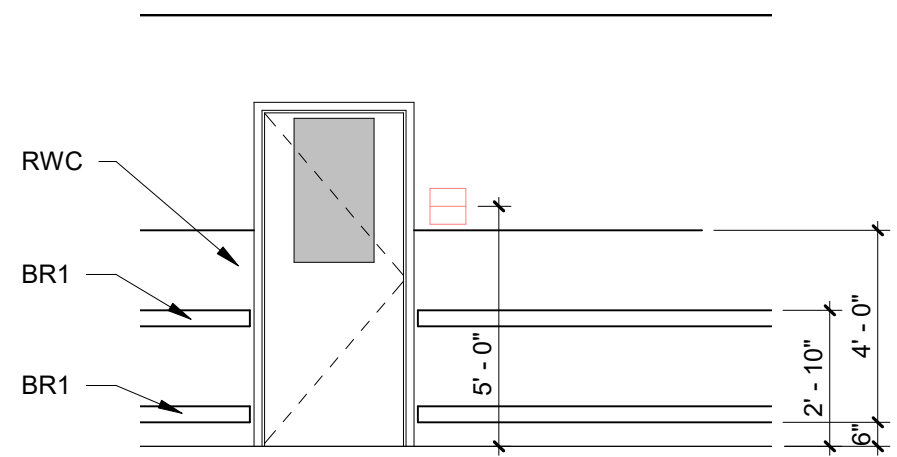2 CORRIDOR - TYPICAL WALL PROTECTION (AT HANDRAIL)
1/4" = 1'-0"



3 CORRIDOR - WALL PROTECTION (NON-HANDRAIL)
1/4" = 1'-0"

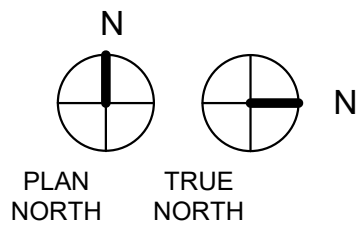1 WALL PROTECTION PLAN - 3RD LEVEL
1/8" = 1'-0"




CONSTRUCTION DOCUMENTS

COMPLIANCY REVIEW INCLUDED Revisions: 2/23/2024 Date		CONSULTANTS:  TERRASITE DESIGN 1635 DEADWOOD AVENUE RAPID CITY, SOUTH DAKOTA 57702 PH: (605) 791-1736  ALBERTSON ENGINEERING, INC. 315 NORTH MAIN AVENUE, SUITE 200 SIOUX FALLS, SOUTH DAKOTA 57104 PH: (605) 274-0880  FARRIS ENGINEERING OMAHA (BRANCH) SENECA COSSAHO (BRANCH) OMAHA, NEBRASKA 68154 PH: (402) 330-5900		ARCHITECT  FOURFRONT DESIGN, INC. 517 7TH STREET RAPID CITY, SOUTH DAKOTA 57701 PH: (605) 342-9470 FAX: (605) 342-2377 WWW.FOURFRONTDESIGN.COM		Drawing Title WALL PROTECTION PLANS - ALTERNATIVE BID #4 Approved: Project Director Omaha VA Medical Center		Project Title Design/Construct Sterile Processing Service- Omaha VA Medical Center Location 4101 Woolworth Ave #4199 Omaha, Ne 68105 Date 11/23/2020 Checked JL Drawn JGC		Project Number 16.2330.A08 Building Number 25 Drawing Number A-512.1 Dwg. 70 of 193		Office of Construction and Facilities Management  Department of Veterans Affairs	
--	--	--	--	---	--	---	--	---	--	---	--	--	--


GENERAL NOTES:

1. SHEET SIZE FOR PROPER SCALE IS 30X42. CONTRACTOR SHALL NOT SCALE DRAWINGS BUT SHALL REQUEST THE DESIRED DIMENSIONS FROM THE ARCHITECT.
2. SEE SHEET G-002 FOR GENERAL NOTES

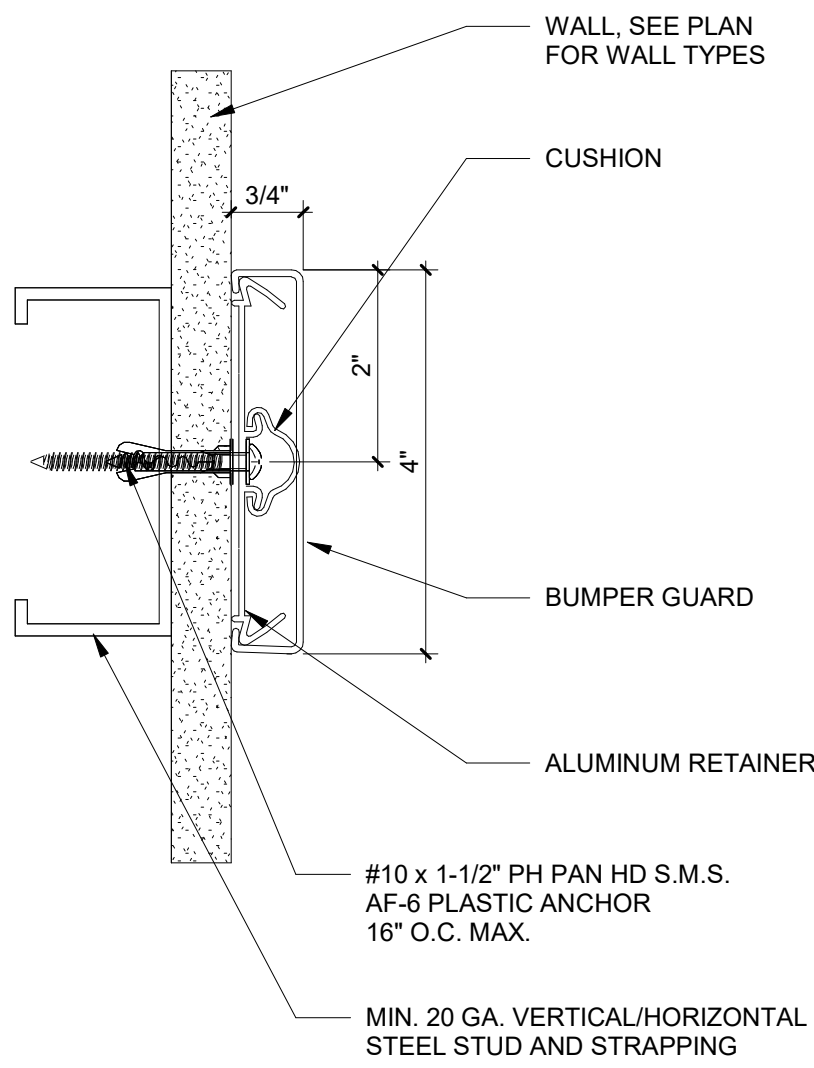
1 BUMPER RAIL DETAIL
6" = 1'-0"




2 CORNER GUARD AT COLUMNS
6" = 1'-0"

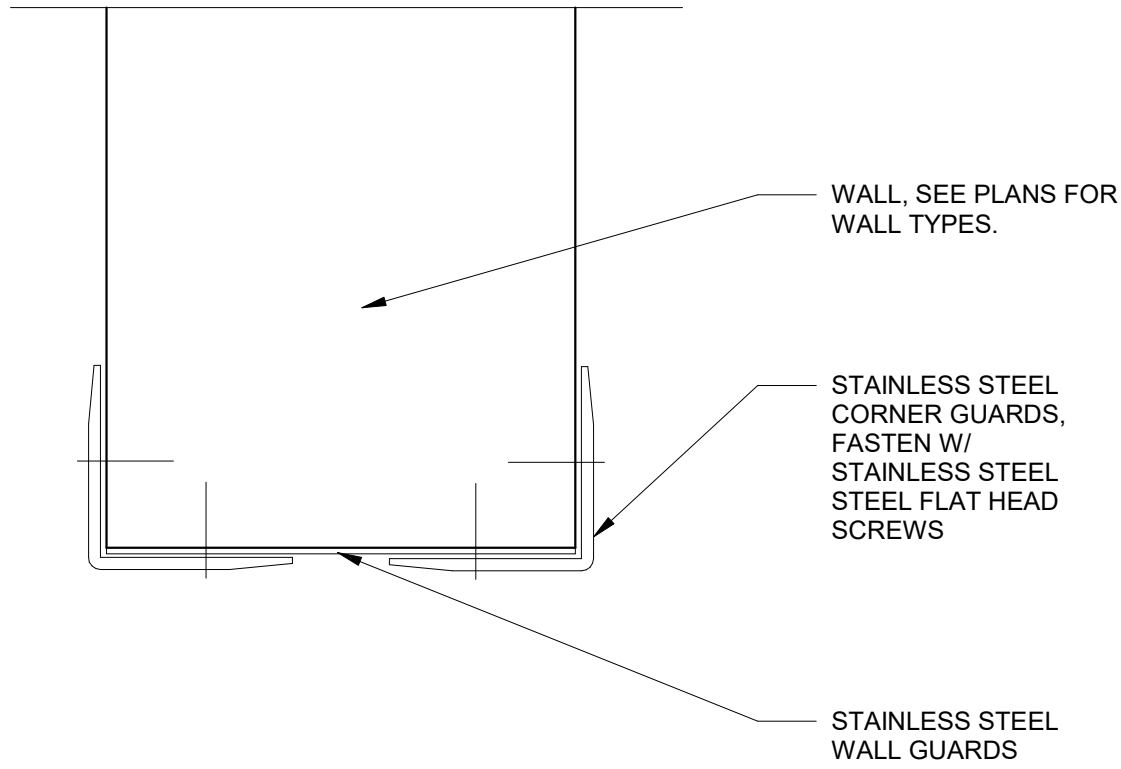


3 CORNER GUARD DETAIL
6" = 1'-0"

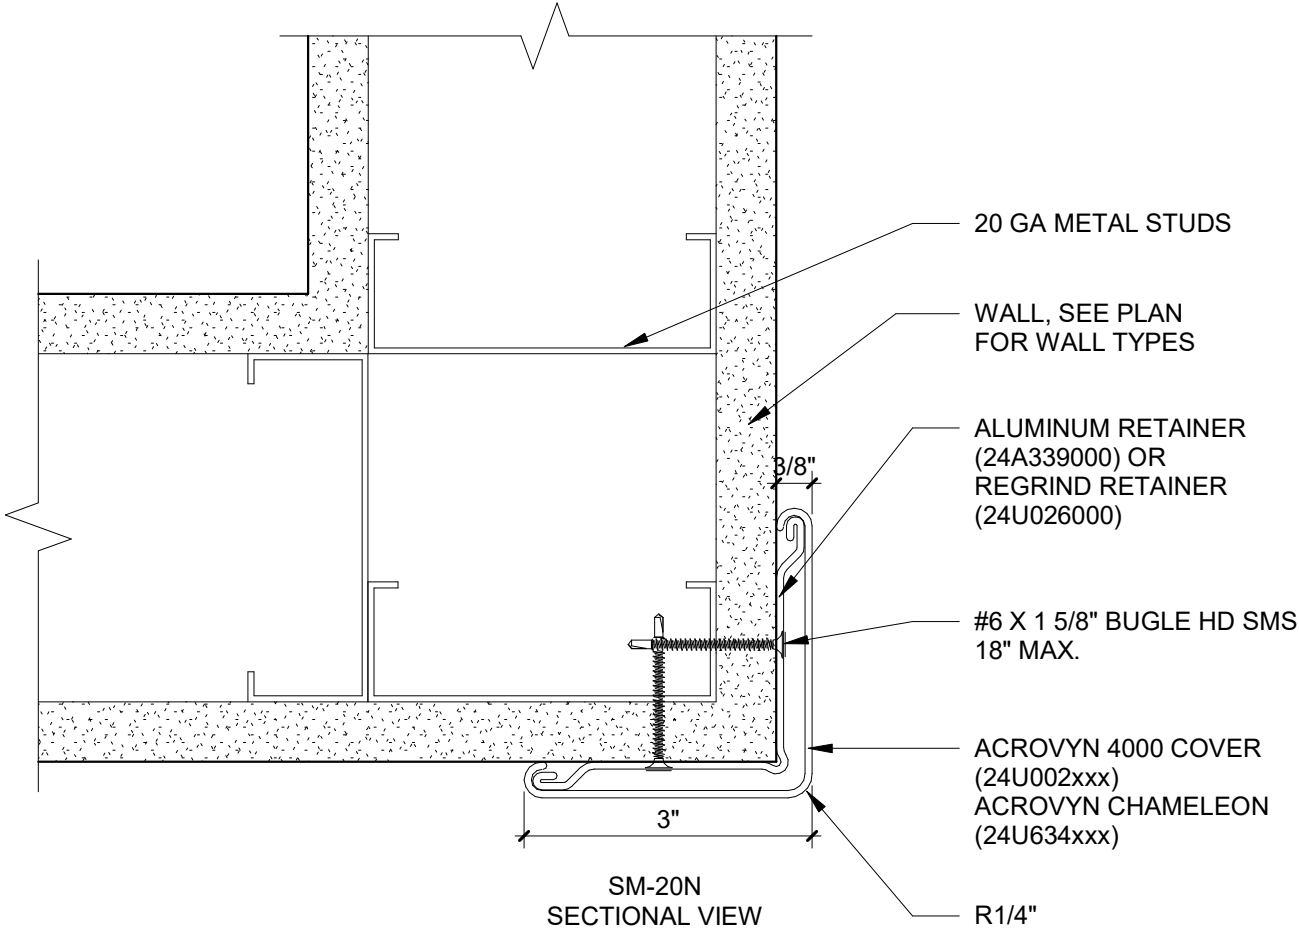


4 CORNER GUARD - STEEL
6" = 1'-0"

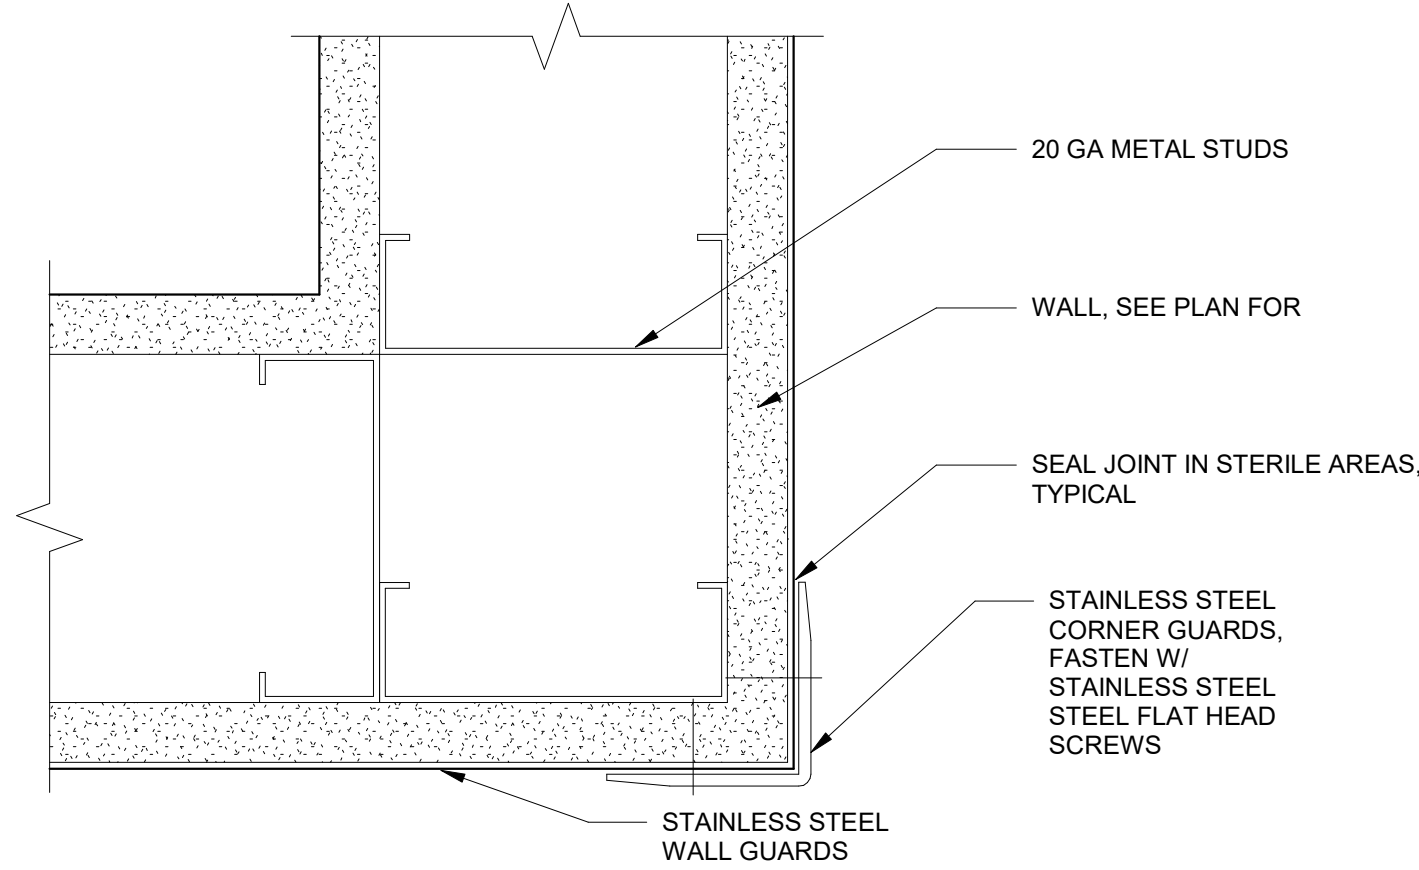


5 HANDRAIL DETAIL
6" = 1'-0"

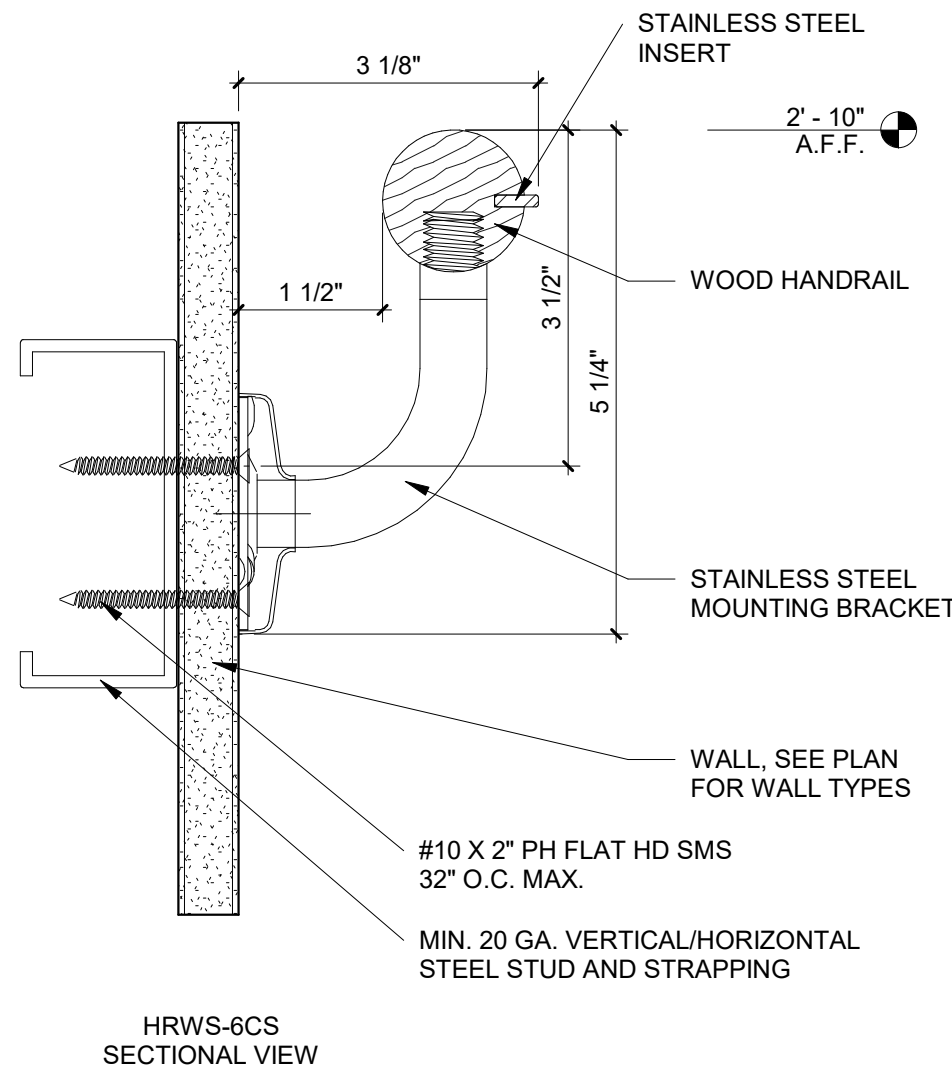


6 RWC DETAILS
12" = 1'-0"

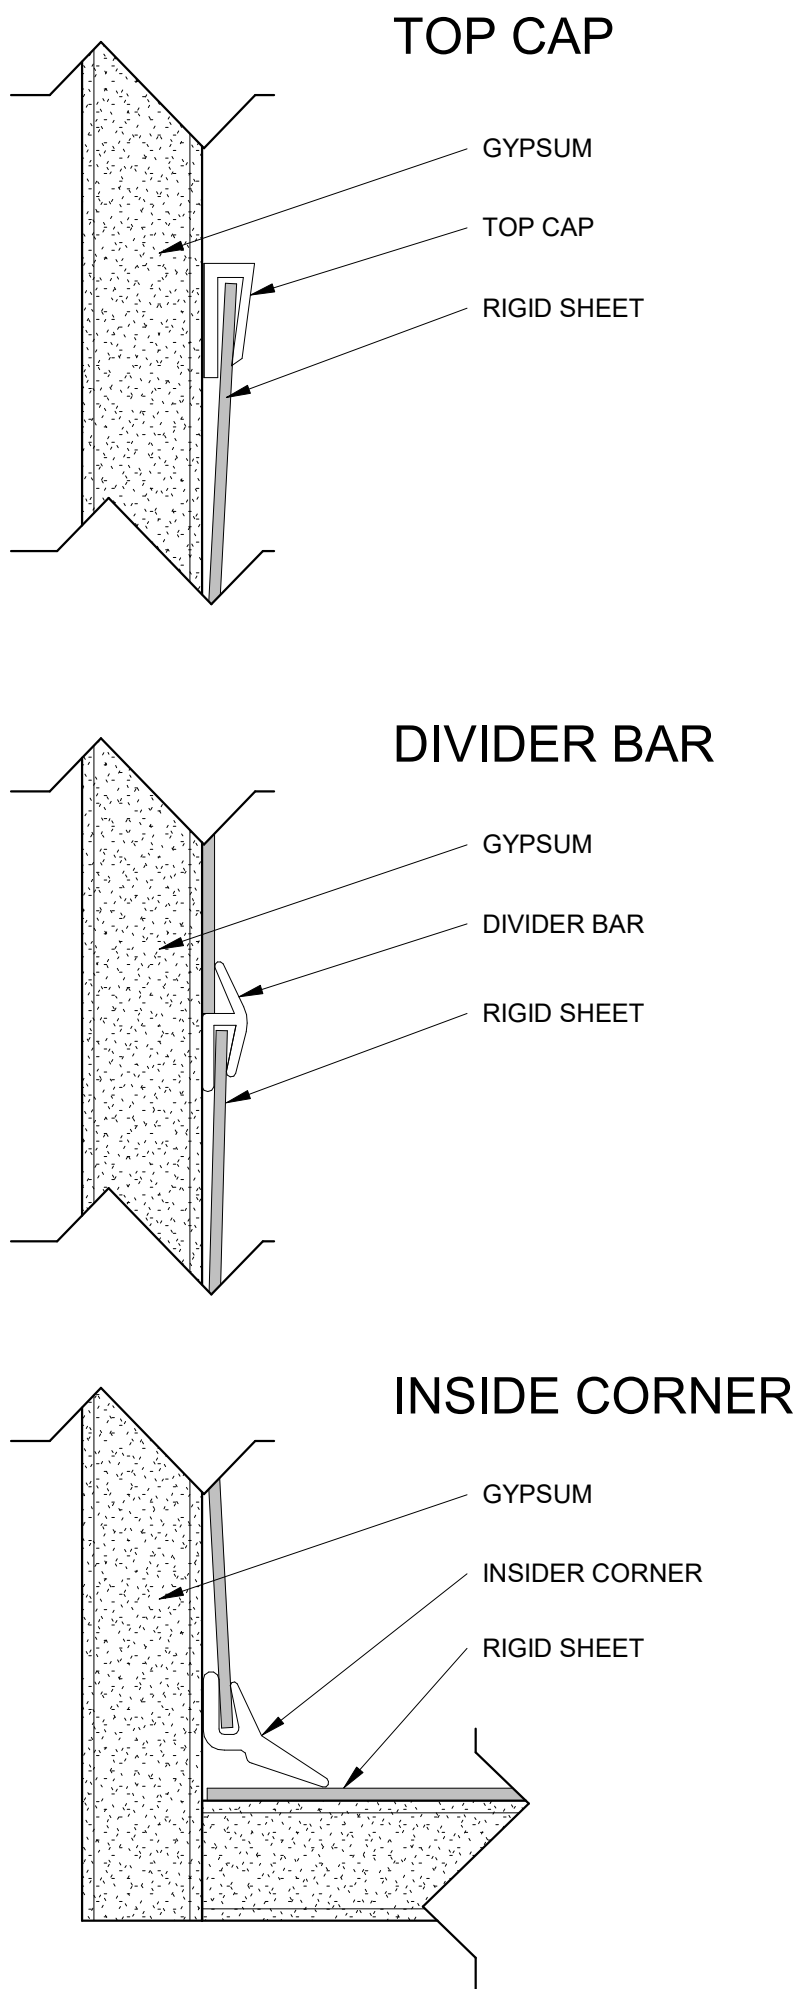

7 RWC DETAIL
6" = 1'-0"

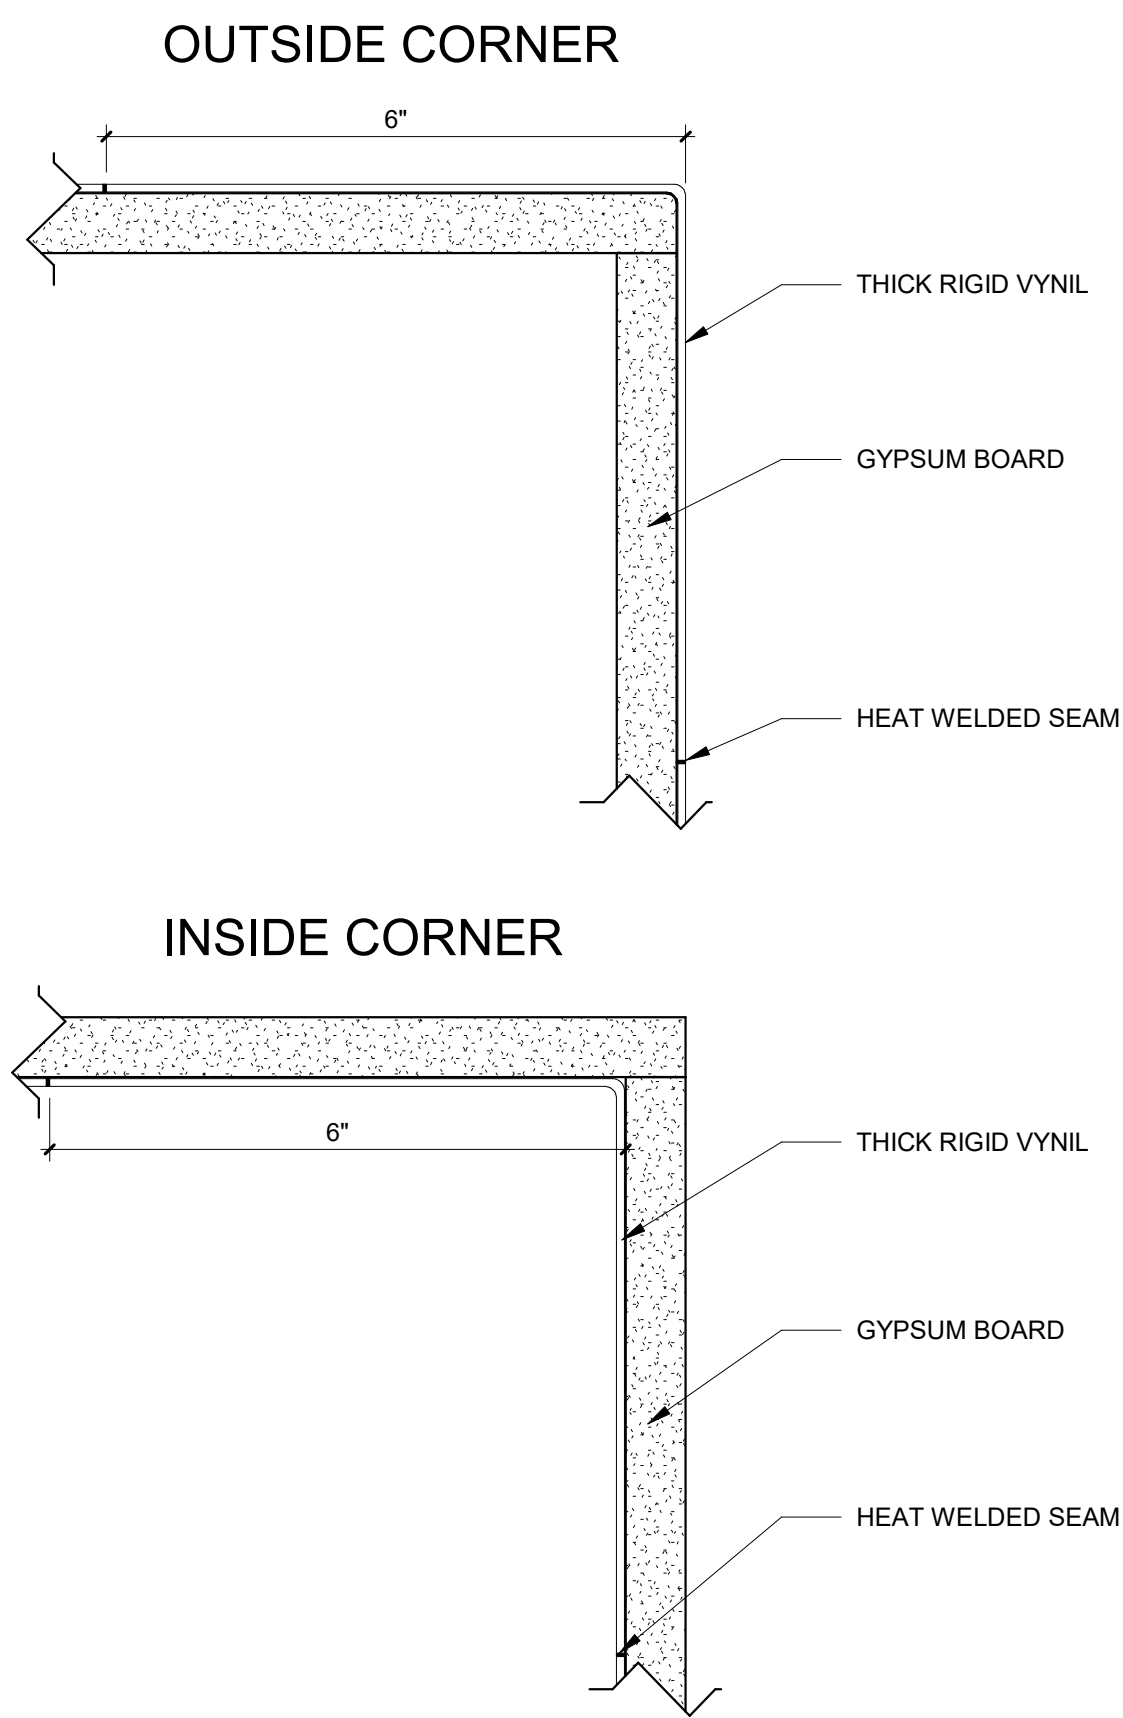

8 STERIL WALL DETAIL
6" = 1'-0"

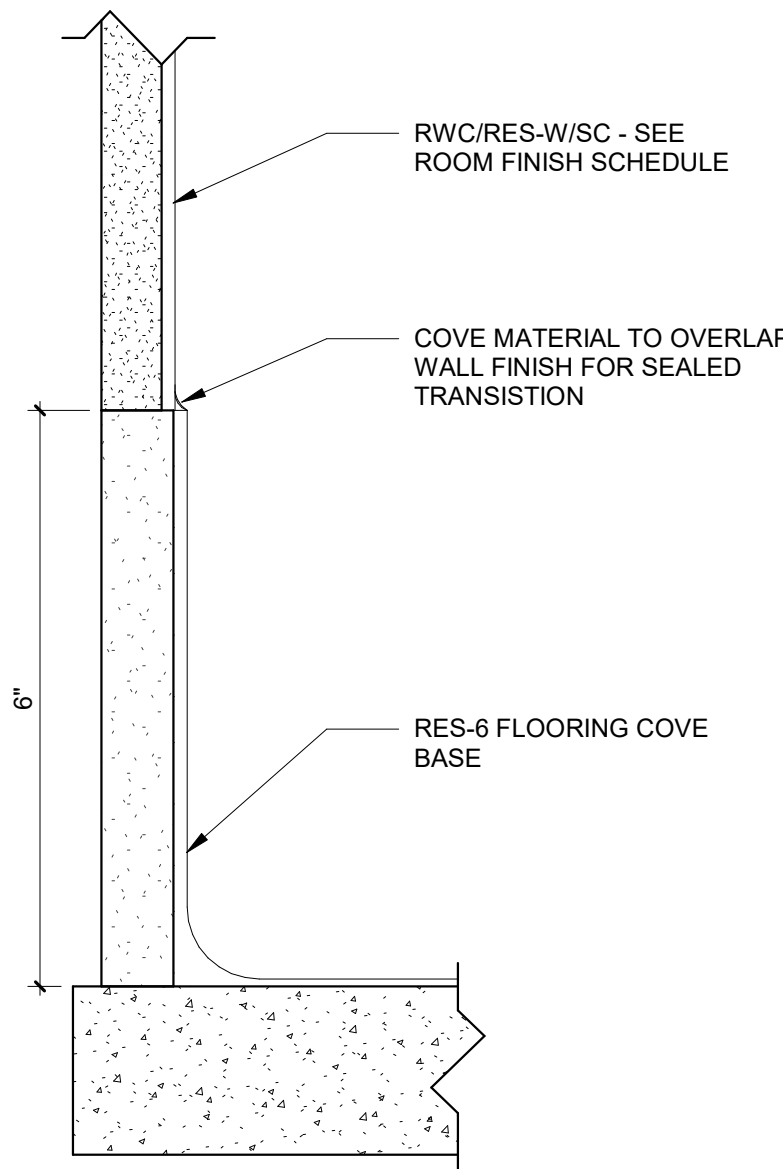

CONSTRUCTION DOCUMENTS

COMPLIANCY REVIEW INCLUDED		2/23/2024	Date		Revisions:	
CONSULTANTS:		ARCHITECT		Drawing Title		WALL PROTECTION DETAILS
TERRASITE DESIGN 1635 DEADWOOD AVENUE RAPID CITY, SOUTH DAKOTA 57702 PH: (605) 791-1736		FARRIS ENGINEERING OMAHA [BNC024] [BENT] [COUNCIL] [BNC024] FARRIS ENGINEERING 12700 WEST DODGE ROAD OMAHA, NEBRASKA 68154 PH: (402) 330-5900		Project Title		Design/Construct Sterile Processing Service- Omaha VA Medical Center
ALBERTSON ENGINEERING, INC. 315 NORTH MAIN AVENUE, SUITE 200 SIOUX FALLS, SOUTH DAKOTA 57104 PH: (605) 274-0880		FOURFRONT DESIGN, INC. 517 7TH STREET RAPID CITY, SOUTH DAKOTA 57701 PH: (605) 342-9470 FAX: (605) 342-2377 WWW.FOURFRONTDESIGN.COM		Project Number		16.2330.A08
FARRIS ENGINEERING OMAHA [BNC024] [BENT] [COUNCIL] [BNC024] FARRIS ENGINEERING 12700 WEST DODGE ROAD OMAHA, NEBRASKA 68154 PH: (402) 330-5900		FOURFRONT DESIGN, INC.		Building Number		25
Approved: Project Director		Location		Drawing Number		A-513
Omaha VA Medical Center		4101 Woolworth Ave #4199 Omaha, Ne 68105		Date		11/23/2020
Checked		Drawn		Dwg. 71 of 193		
JL		JGC		Department of Veterans Affairs		

GENERAL NOTES:


1. SHEET SIZE FOR PROPER SCALE IS 30X42. CONTRACTOR SHALL NOT SCALE DRAWINGS BUT SHALL REQUEST THE DESIRED DIMENSIONS FROM THE ARCHITECT.
2. SEE SHEET G-002 FOR GENERAL NOTES.
3. APPLY 1 1/2" THICK FIREPROOFING AT ALL EXPOSED STEEL WITHIN INTERSTITIAL SPACE AND AT EXPOSED STEEL STRUCTURE ABOVE 3RD FLOOR CEILING, TYP.

SHEET SPECIFIC NOTES:



1. BRING BOTTOM OF CORNER GUARDS 4" AFF.

KEYNOTES:


- | | |
|-------|--|
| 09-30 | PT-1, PORCELAIN TILE, SEE SPECIFICATION. |
| 09-31 | PT-2, PORCELAIN TILE, SEE SPECIFICATION. |
| 09-33 | METAL BULLNOSE TRIM, SEE SPECIFICATION. |
| 09-34 | METAL COVE TRIM, SEE SPECIFICATION. |
| 09-52 | SOFFIT, SEE ROOM FINISH SCHEDULE FOR PAINT. |
| 10-15 | WARDROBE HOOKS, SEE SPECIFICATION. |
| 10-16 | FULL LENGTH MIRROR, SEE SPECIFICATION. |
| 10-18 | 24" GRAB BAR, SEE SPECIFICATION. |
| 10-22 | MIRROR, SEE SPECIFICATION. |
| 10-23 | 18" GRAB BAR, SEE SPECIFICATION. |
| 10-24 | 36" GRAB BAR, SEE SPECIFICATION. |
| 10-25 | 42" GRAB BAR, SEE SPECIFICATION. |
| 10-26 | RWC, RIGID VINYL WALL PROTECTION, SEE SPECIFICATION. |
| 10-29 | SURFACE MOUNTED TOILET PAPER HOLDER, SEE SPECIFICATION. |
| 10-30 | SURFACE MOUNTED PAPER TOWEL DISPENSER, SEE SPECIFICATION. |
| 10-37 | SOAP DISPENSER (A5075), VA PROVIDED, CONTRACTOR INSTALLED. |
| 10-50 | LOCKERS, SEE DETAILS ON SHEET. |
| 10-53 | ADA BENCH, SEE SPECIFICATION. |
| 22-01 | PLUMBING FIXTURE (REF. MECHANICAL). |

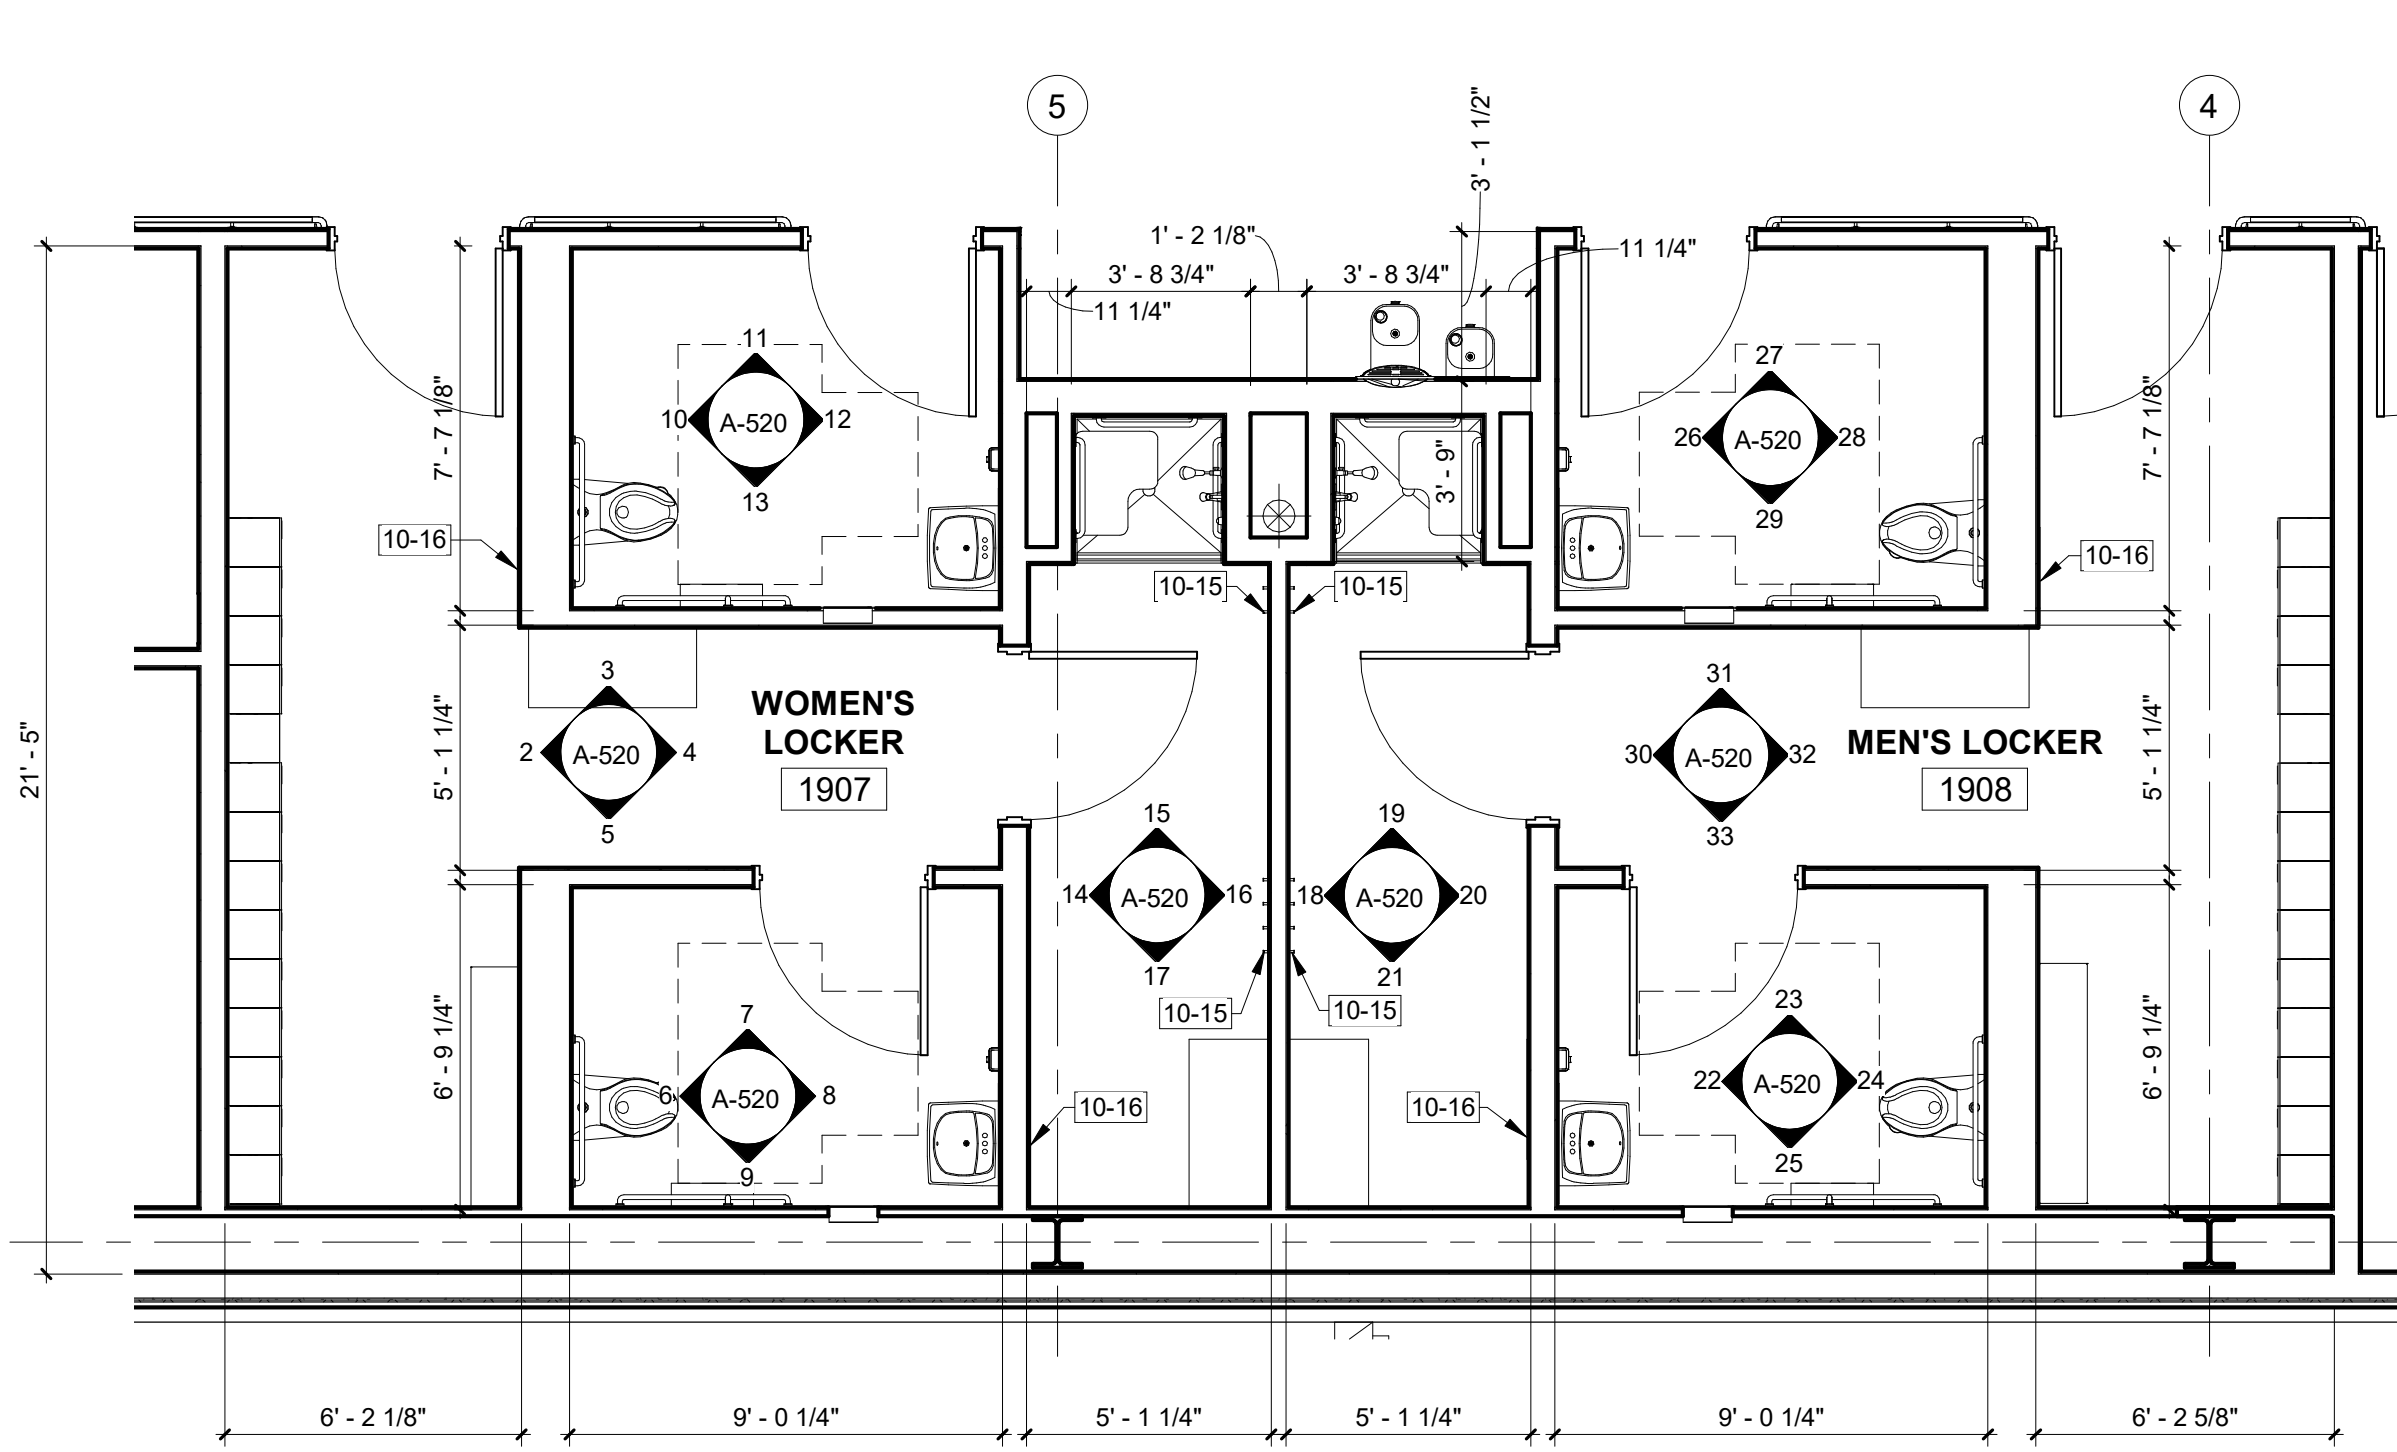

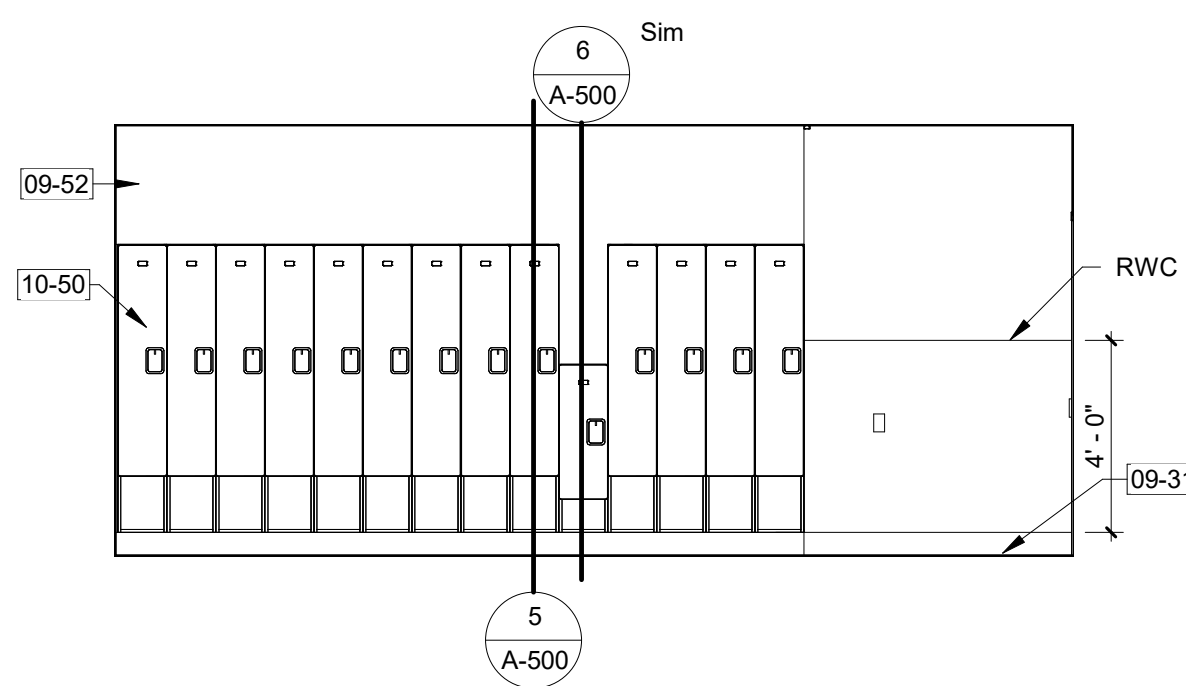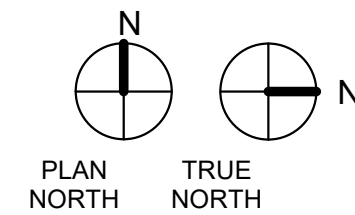
1 RESTROOM FLOOR PLAN - ENLARGED
1/4" = 1'-0"



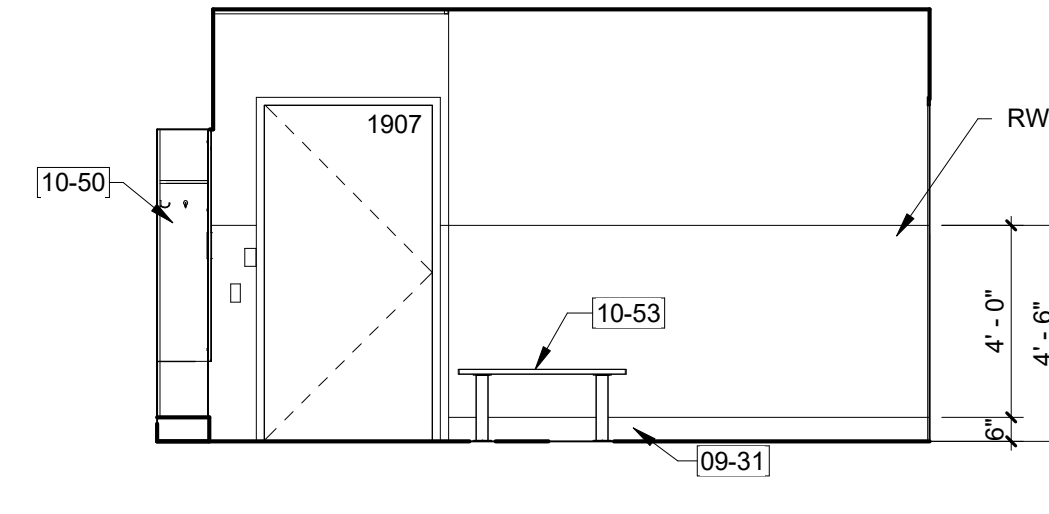
2 WOMENS LOCKER ROOM WEST ELEVATION
1/4" = 1'-0"



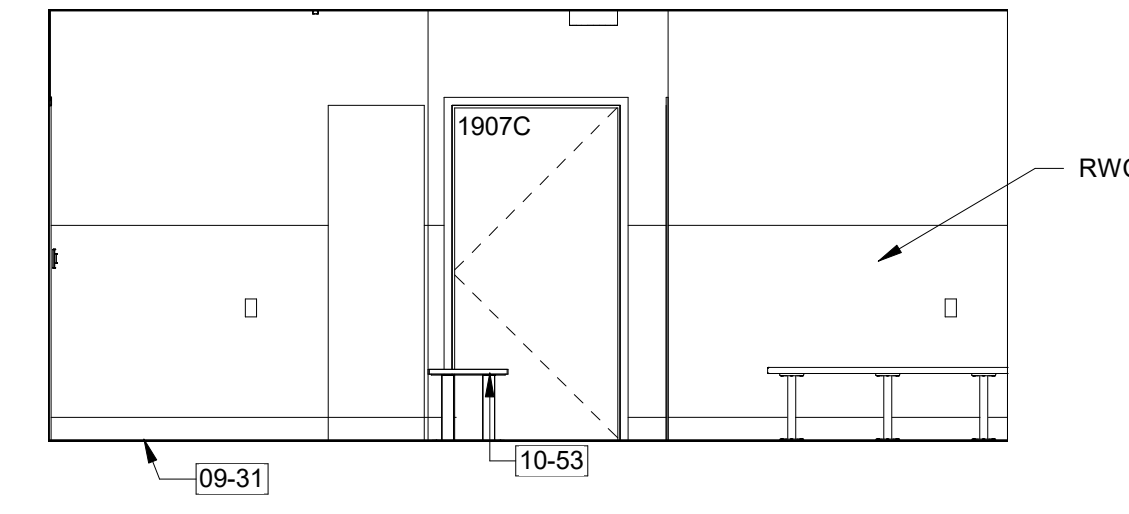
3 WOMENS LOCKER ROOM NORTH ELEVATION
1/4" = 1'-0"



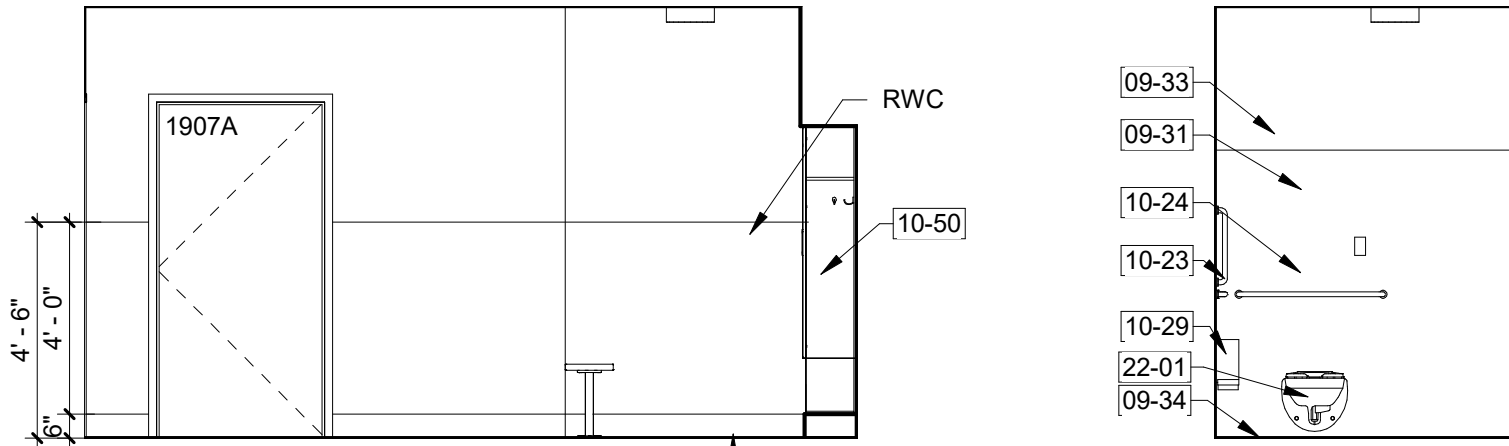
4 WOMENS LOCKER ROOM EAST ELEVATION
1/4" = 1'-0"



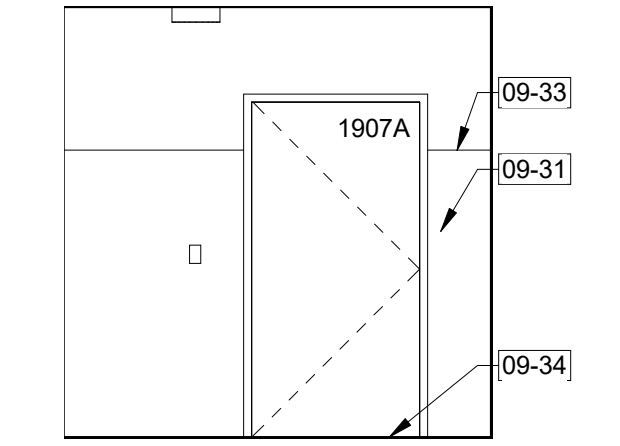
5 WOMENS LOCKER ROOM SOUTH ELEVATION
1/4" = 1'-0"



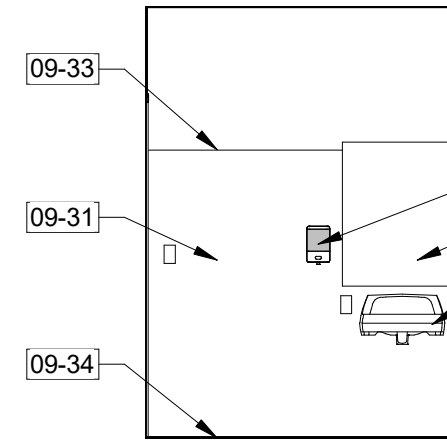6 WOMENS RESTROOM WEST ELEVATION
1/4" = 1'-0"



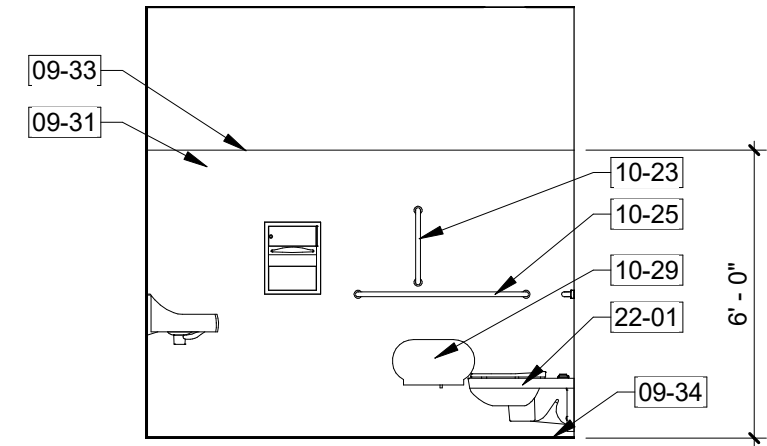
7 WOMENS RESTROOM NORTH ELEVATION
1/4" = 1'-0"




8 WOMENS RESTROOM EAST ELEVATION
1/4" = 1'-0"



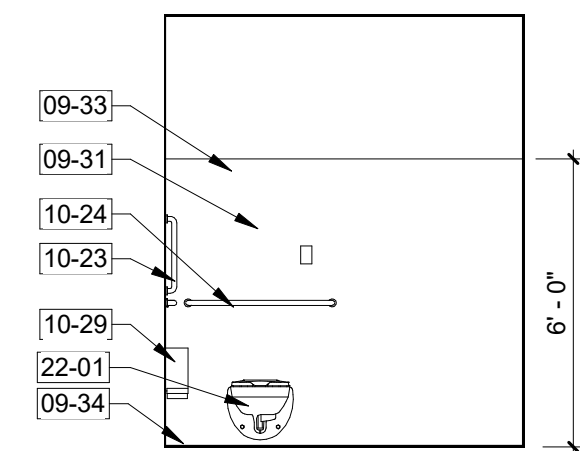
9 WOMENS RESTROOM SOUTH ELEVATION
1/4" = 1'-0"



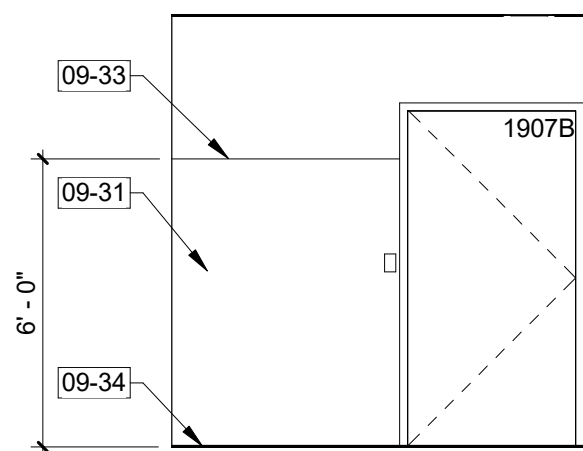
10 WOMENS RESTROOM WEST ELEVATION
1/4" = 1'-0"



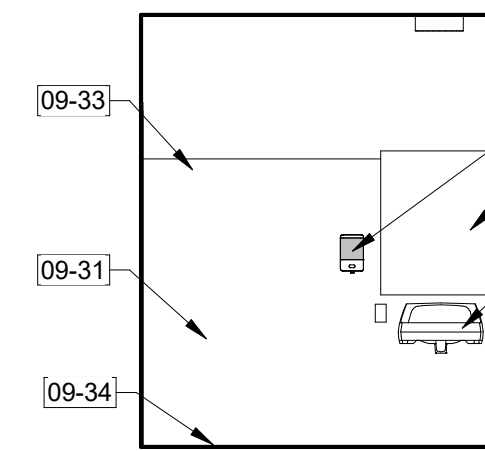
11 WOMENS RESTROOM NORTH ELEVATION
1/4" = 1'-0"



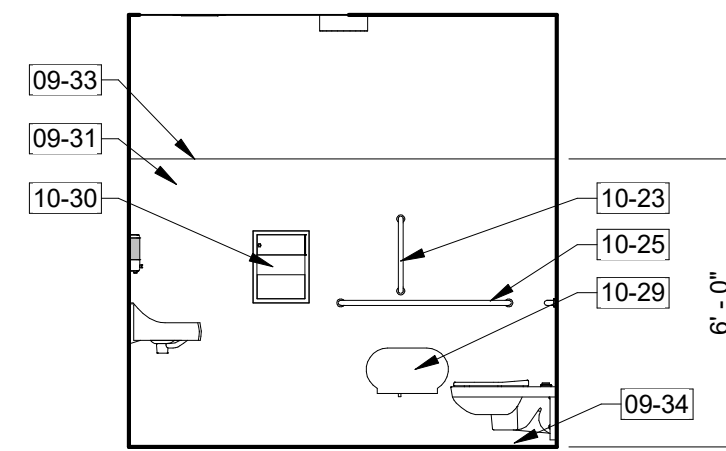
12 WOMENS RESTROOM EAST ELEVATION
1/4" = 1'-0"



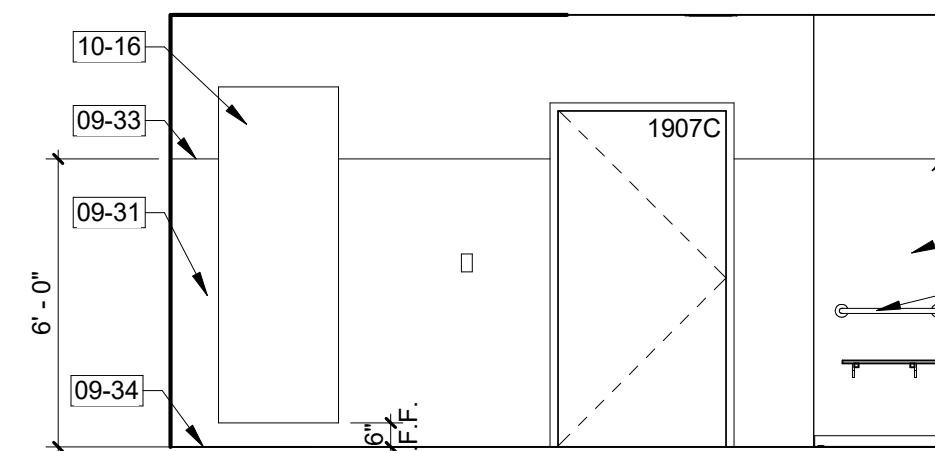
13 WOMENS RESTROOM SOUTH ELEVATION
1/4" = 1'-0"



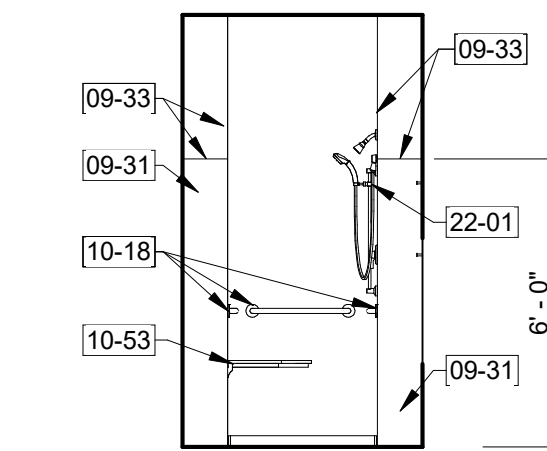
14 WOMENS SHOWER WEST ELEVATION
1/4" = 1'-0"



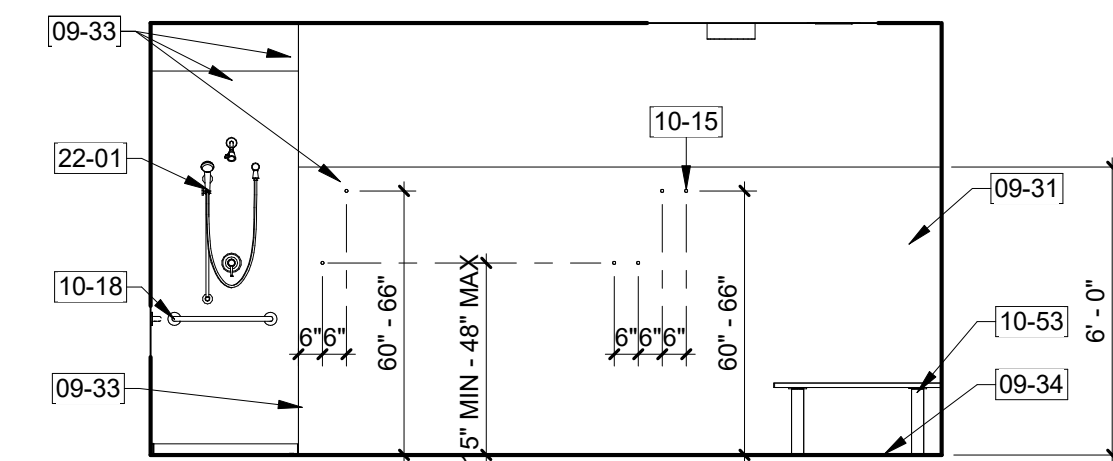
15 WOMENS SHOWER NORTH ELEVATION
1/4" = 1'-0"



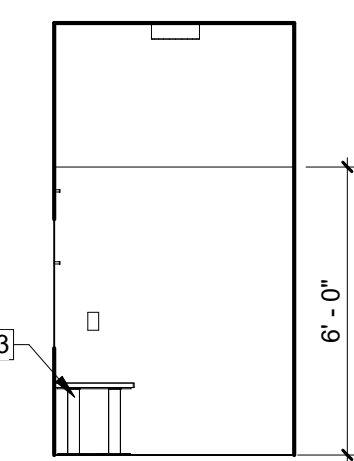
16 WOMENS SHOWER EAST ELEVATION
1/4" = 1'-0"



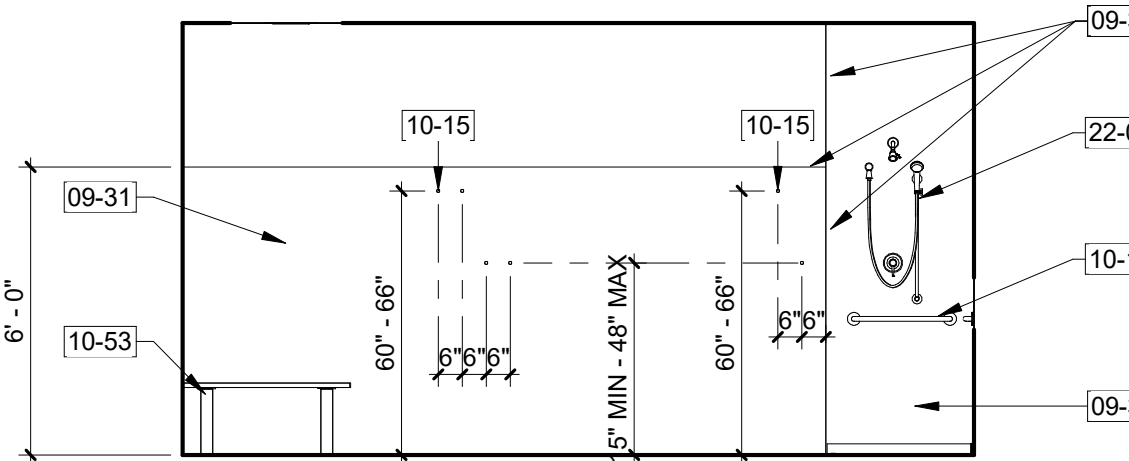
17 WOMENS SHOWER SOUTH ELEVATION
1/4" = 1'-0"



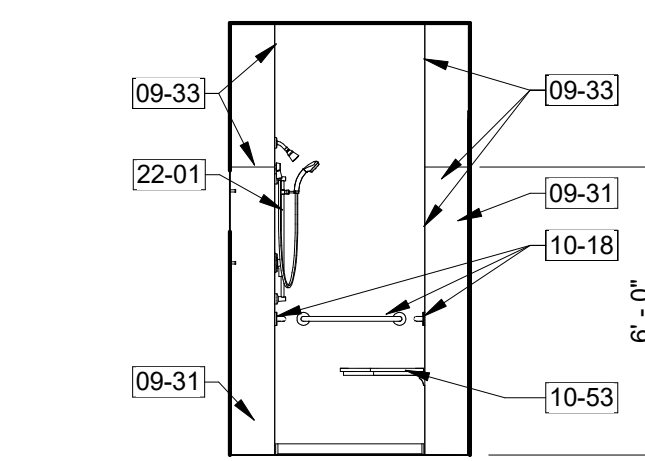
18 MENS SHOWER WEST ELEVATION
1/4" = 1'-0"



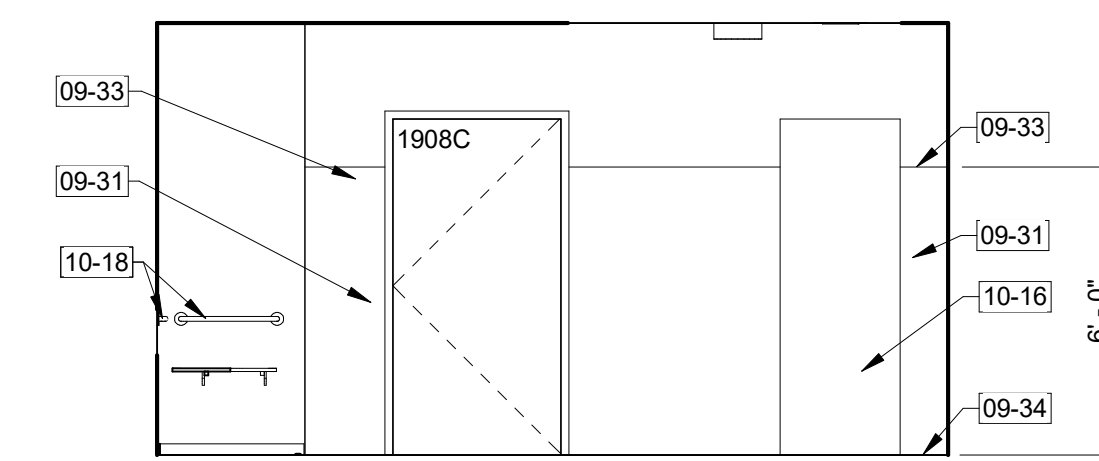
19 MENS SHOWER NORTH ELEVATION
1/4" = 1'-0"



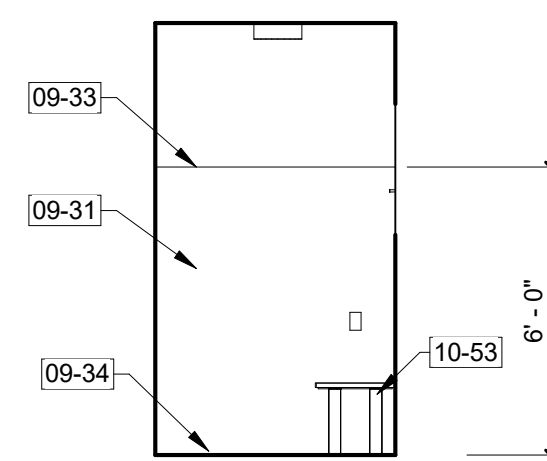
20 MENS SHOWER EAST ELEVATION
1/4" = 1'-0"



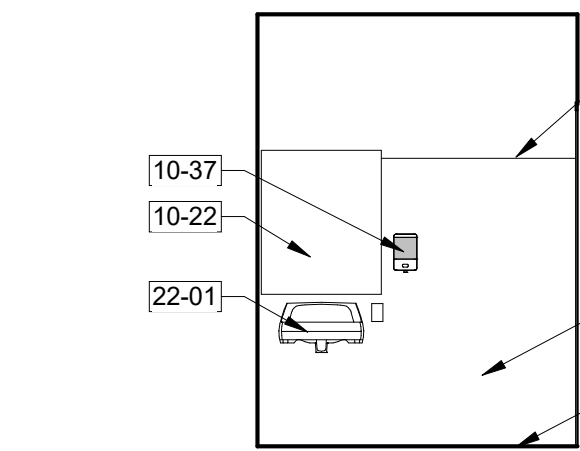
21 MENS SHOWER SOUTH ELEVATION
1/4" = 1'-0"



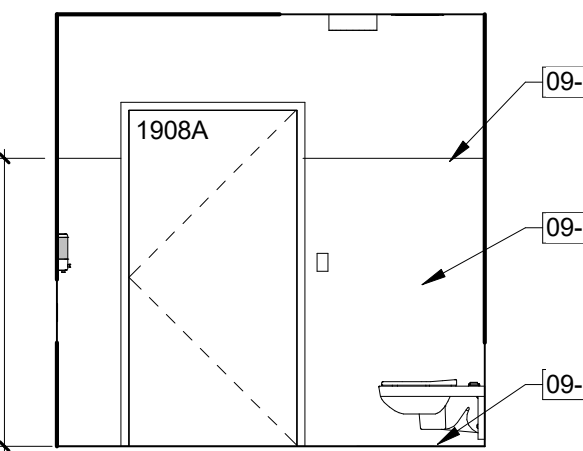
22 MENS RESTROOM WEST ELEVATION
1/4" = 1'-0"



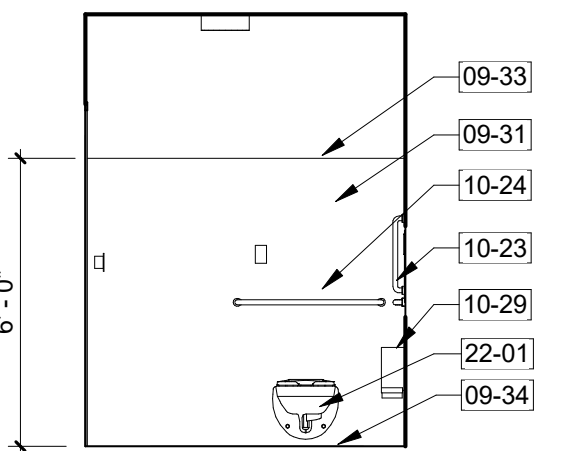
23 MENS RESTROOM NORTH ELEVATION
1/4" = 1'-0"



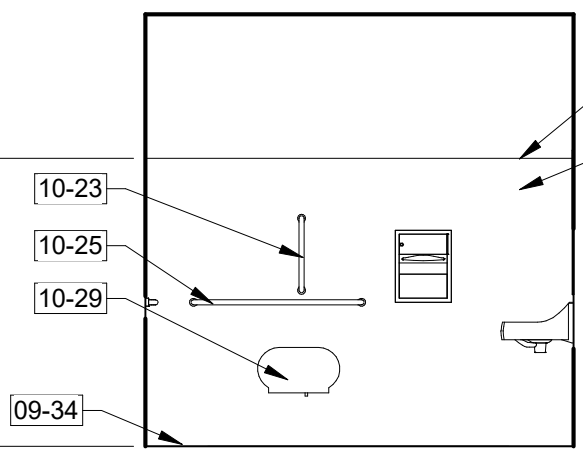
24 MENS RESTROOM EAST ELEVATION
1/4" = 1'-0"



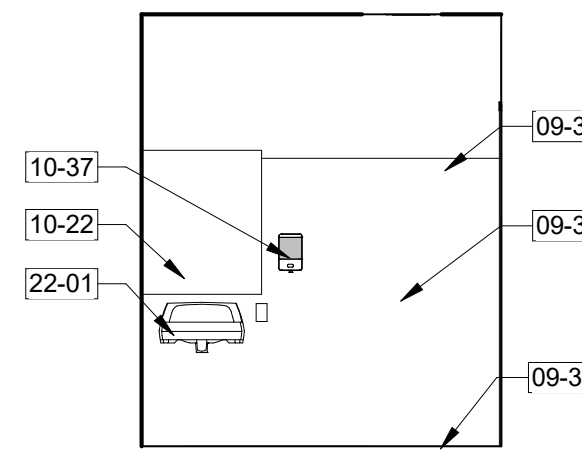
25 MENS RESTROOM SOUTH ELEVATION
1/4" = 1'-0"



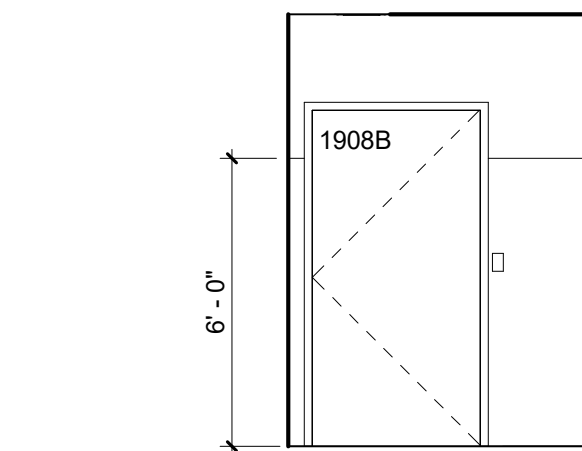
26 MENS RESTROOM WEST ELEVATION
1/4" = 1'-0"



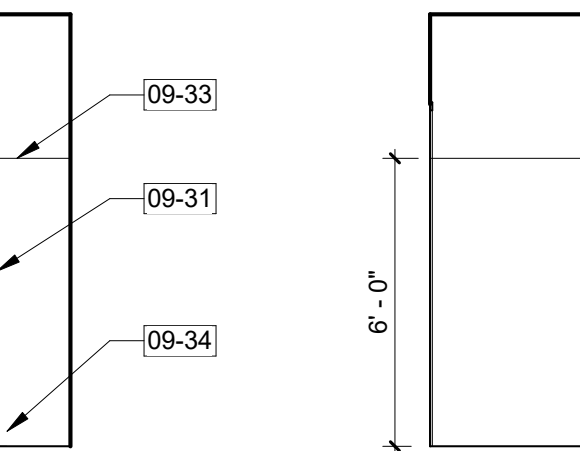
27 MENS RESTROOM NORTH ELEVATION 2
1/4" = 1'-0"



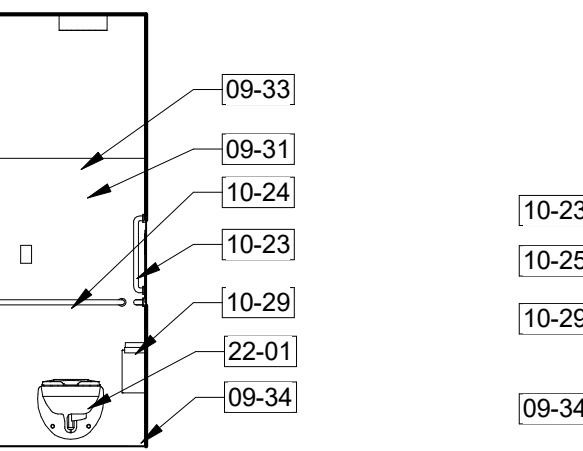
28 MENS RESTROOM EAST ELEVATION 1
1/4" = 1'-0"



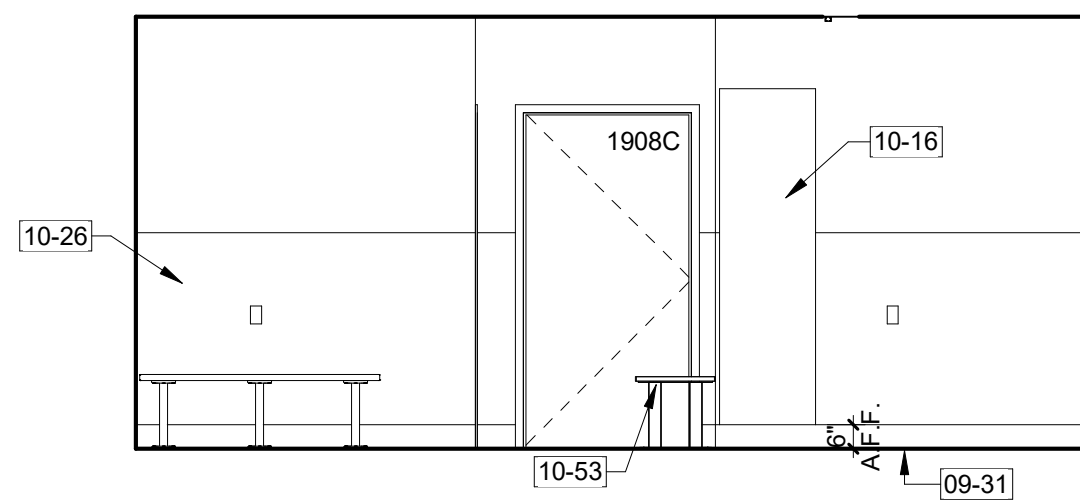
29 MENS RESTROOM SOUTH ELEVATION
1/4" = 1'-0"



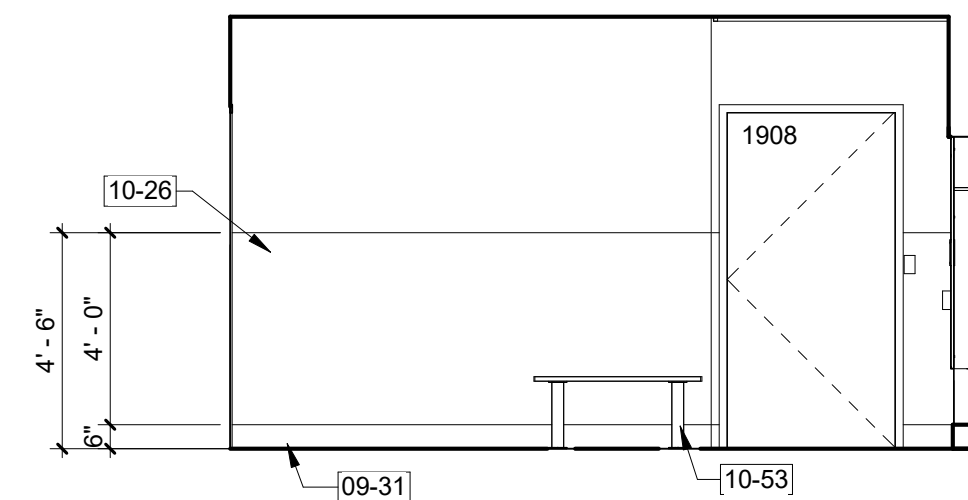
30 MENS LOCKER ROOM WEST ELEVATION
1/4" = 1'-0"



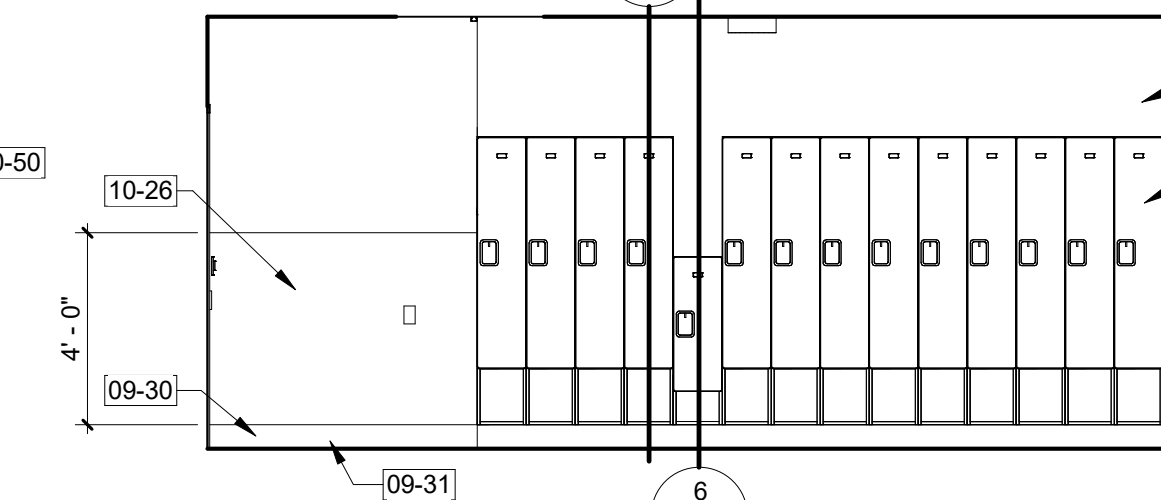31 MENS LOCKER ROOM NORTH ELEVATION
1/4" = 1'-0"



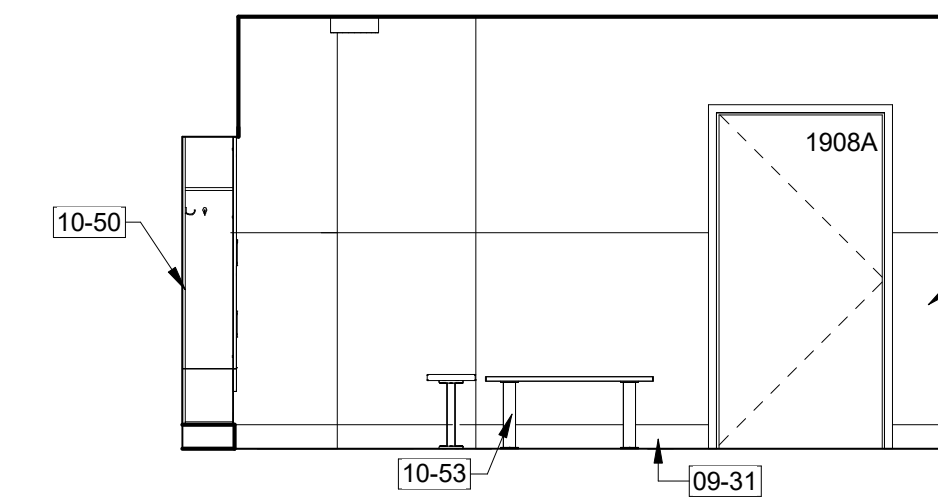32 MENS LOCKER ROOM EAST ELEVATION
1/4" = 1'-0"



33 MENS LOCKER ROOM SOUTH ELEVATION
1/4" = 1'-0"

CONSTRUCTION DOCUMENTS

CONSULTANTS:		ARCHITECT		Drawing Title		Project Title		Project Number		Office of Construction and Facilities Management	
 TERRASITE DESIGN 1635 DEADWOOD AVENUE RAPID CITY, SOUTH DAKOTA 57702 PH: (605) 791-1736		 FOURFRONT DESIGN INC. 517 7TH STREET RAPID CITY, SOUTH DAKOTA 57701 PH: (605) 342-9470 FAX: (605) 342-2377 WWW.FOURFRONTDESIGN.COM		ENLARGED PLAN AND INTERIOR ELEVATIONS		Design/Construct Sterile Processing Service- Omaha VA Medical Center		16.2330.A08		Department of Veterans Affairs	
 ALBERTSON ENGINEERING, INC. 315 NORTH MAIN AVENUE, SUITE 200 SIOUX FALLS, SOUTH DAKOTA 57104 PH: (605) 274-0880		 FARRIS ENGINEERING 12700 WEST DODGE ROAD OMAHA, NEBRASKA 68154 PH: (402) 330-5900		Approved: Project Director Omaha VA Medical Center		Location 4101 Woolworth Ave #4199 Omaha, Ne 68105		Building Number 25		Drawing Number A-520	
COMPLIANCY REVIEW INCLUDED		2/23/2024		Date		Date 11/23/2020		Checked JL		Drawn JGC	
Revisions:		Date		Dwg. 72 of 193							

7/27/2022 11:56:44 AM

one eighth inch = one foot

one quarter inch = one foot

three eighths inch = one foot

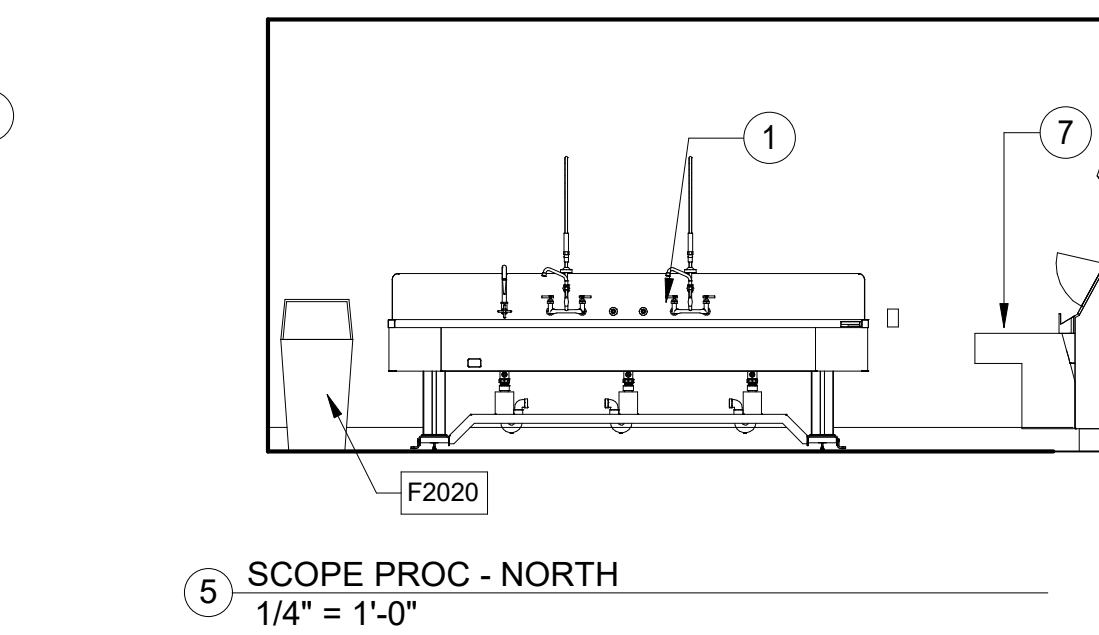
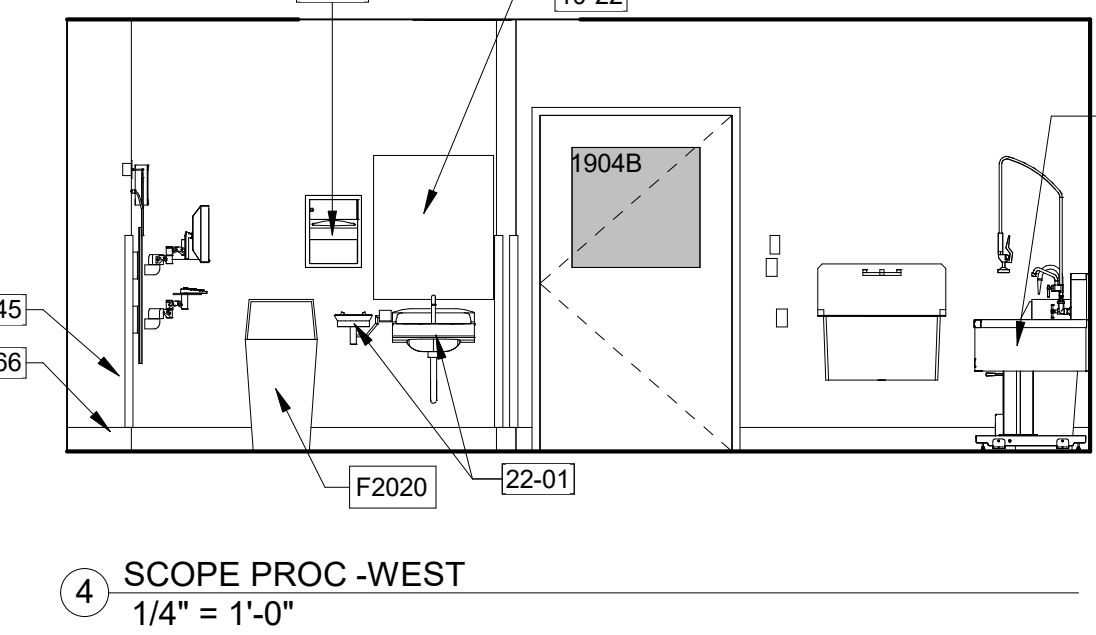
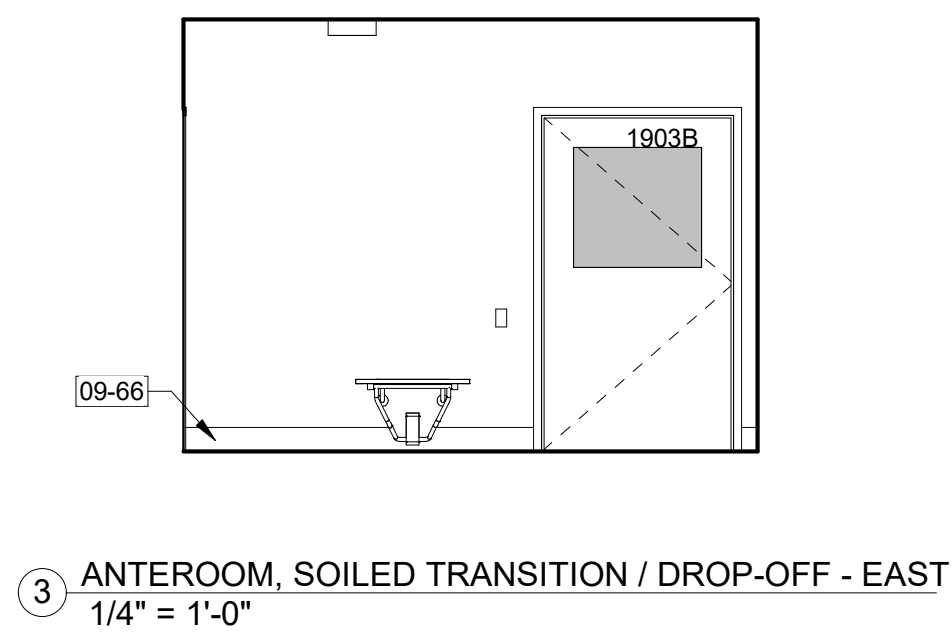
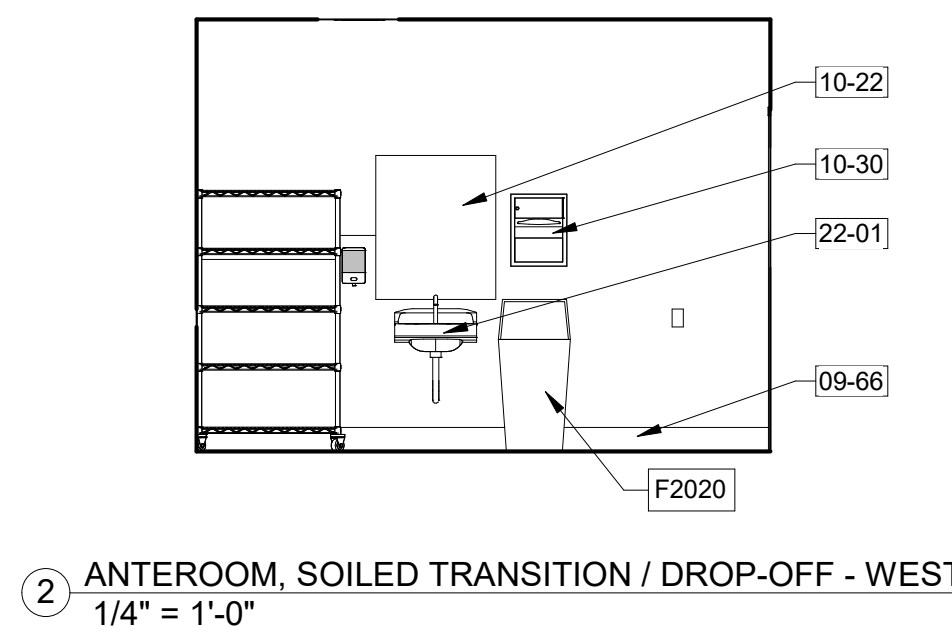
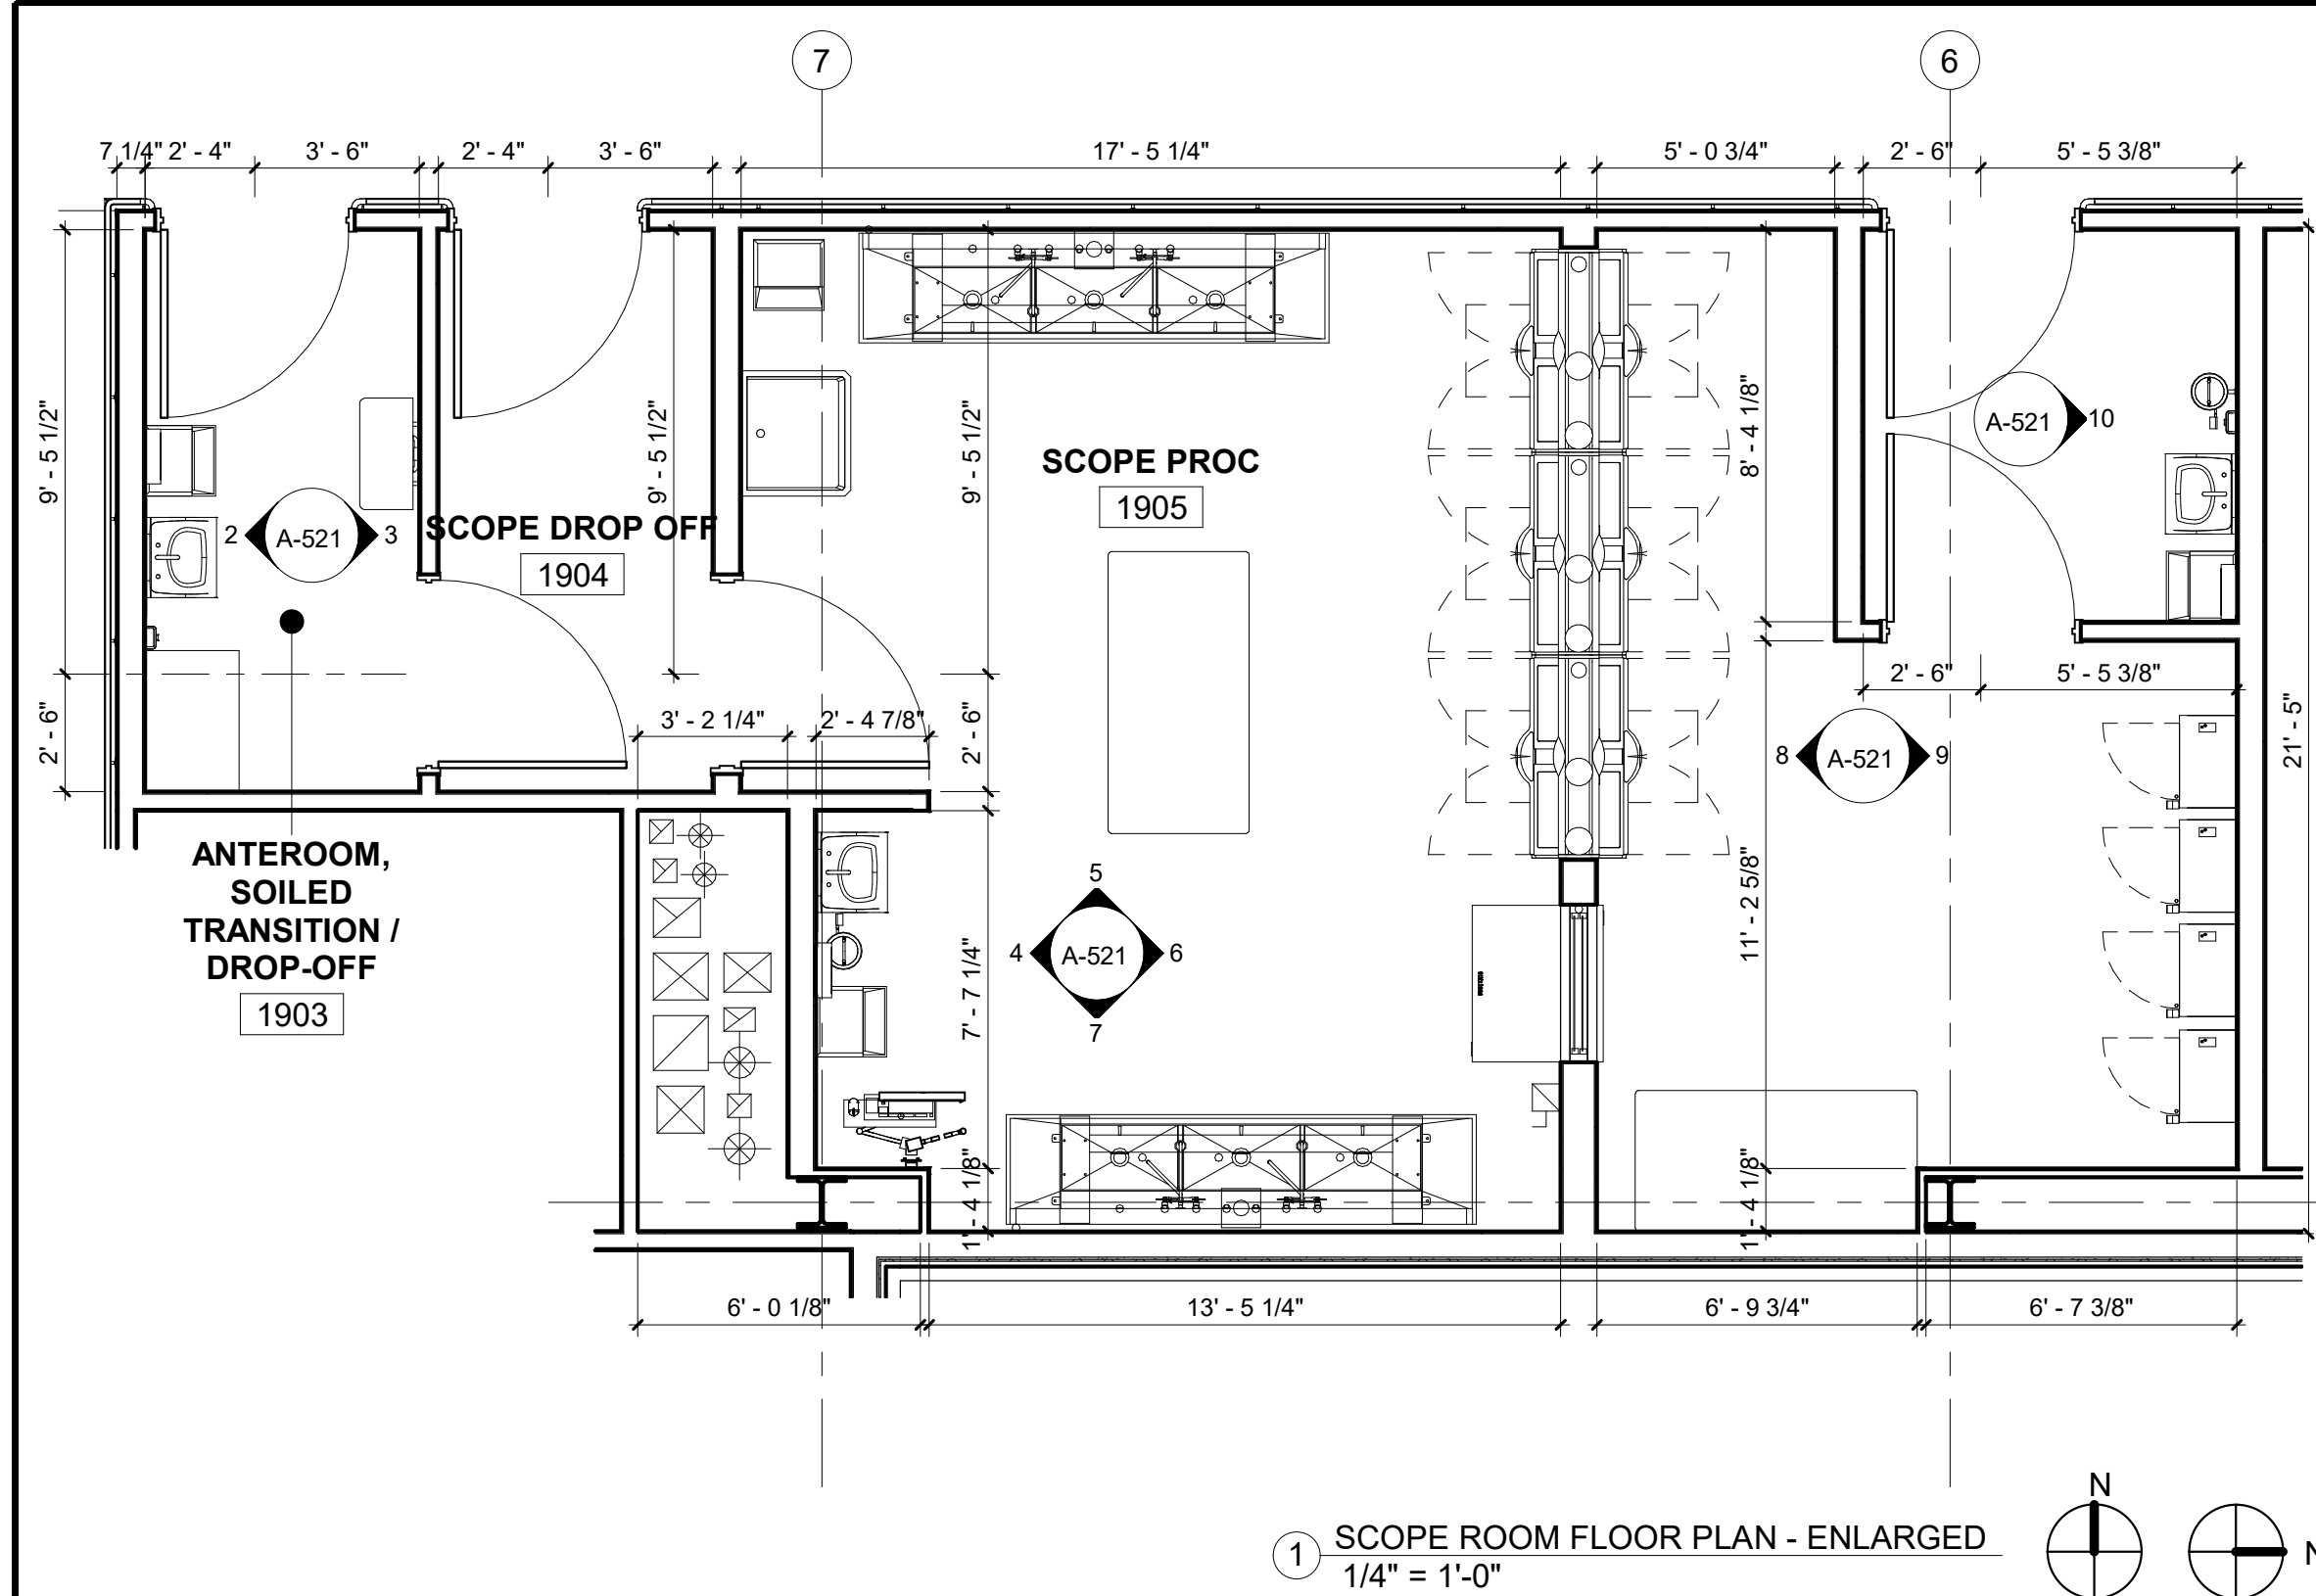
one half inch = one foot

three quarters inch = one foot

one foot one inch = one foot

one and one half inches = one foot

one and one half inches = one foot



GENERAL NOTES:

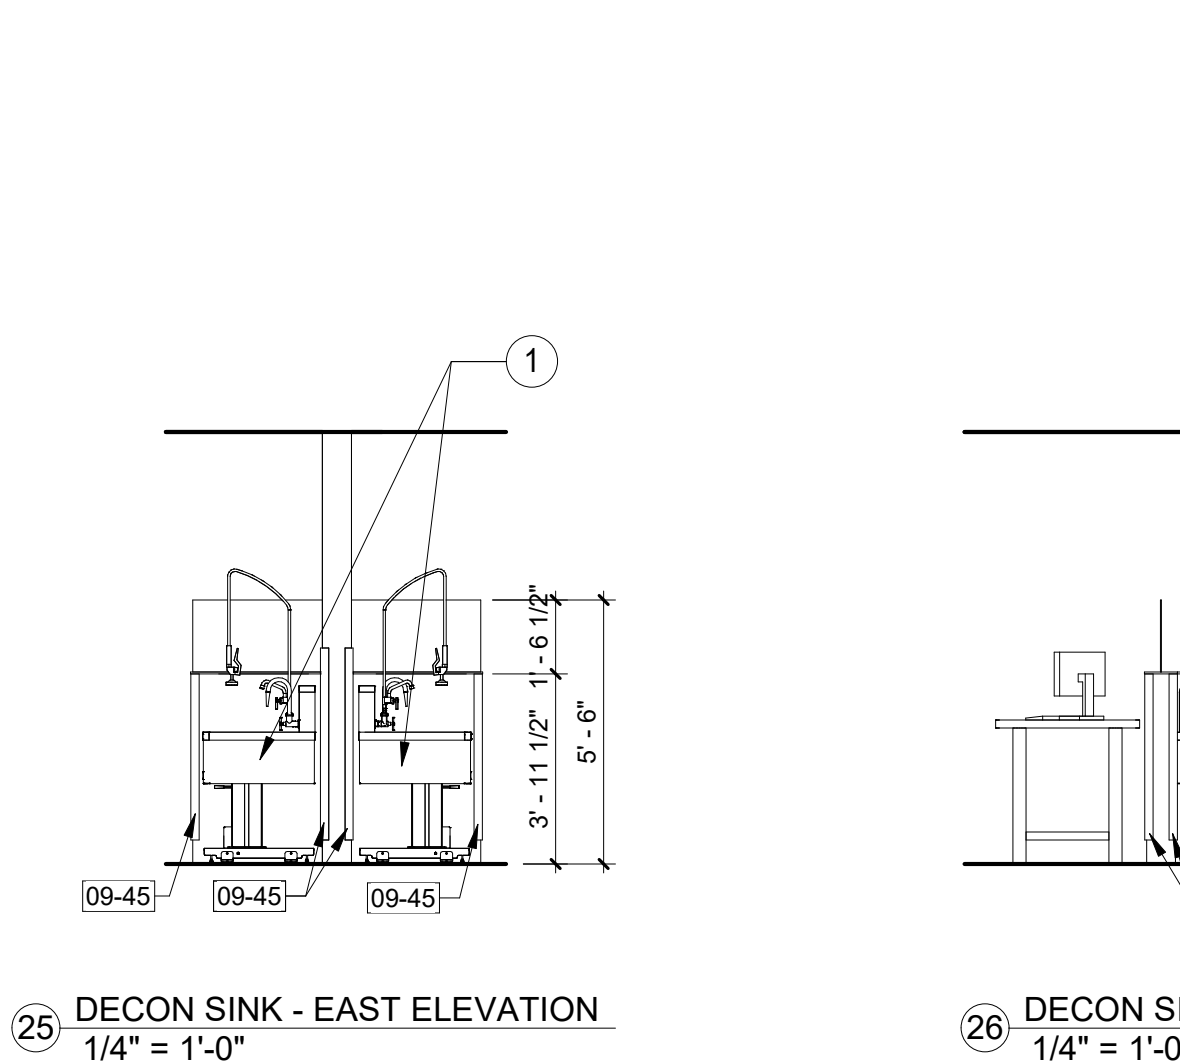
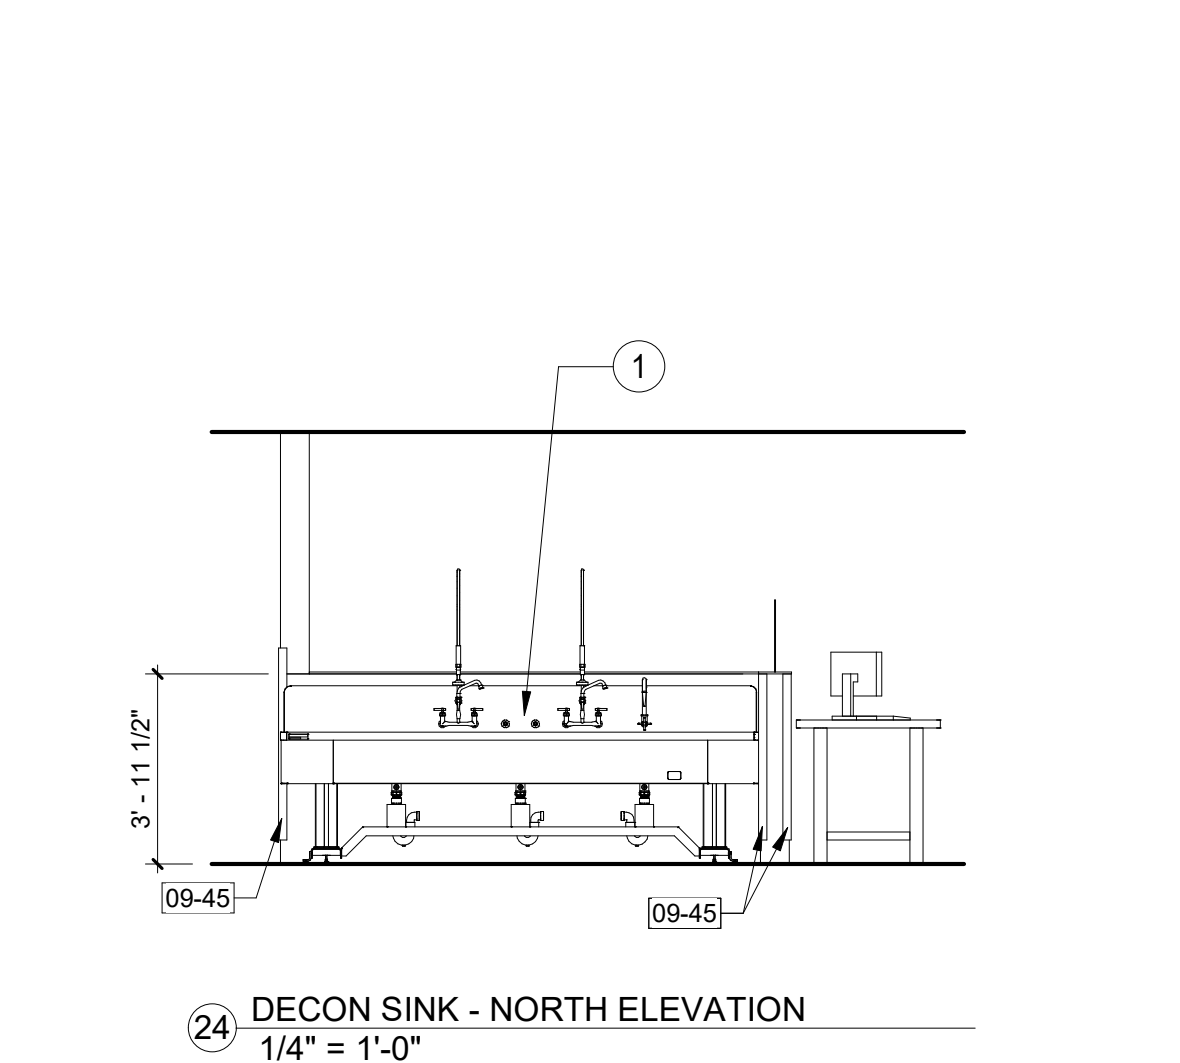
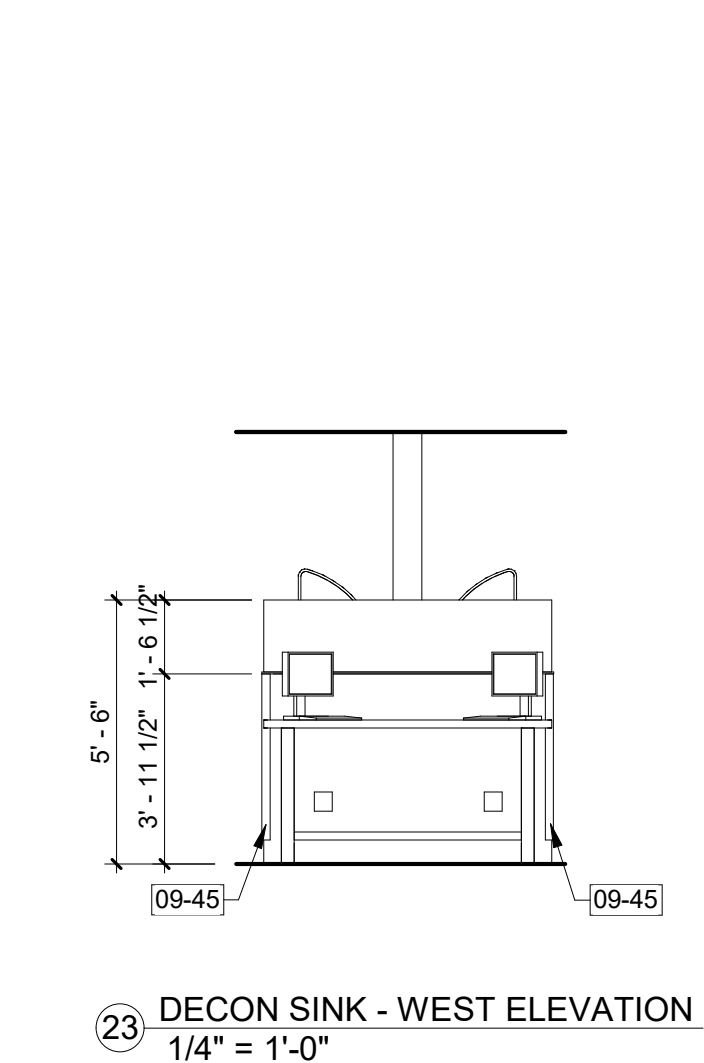
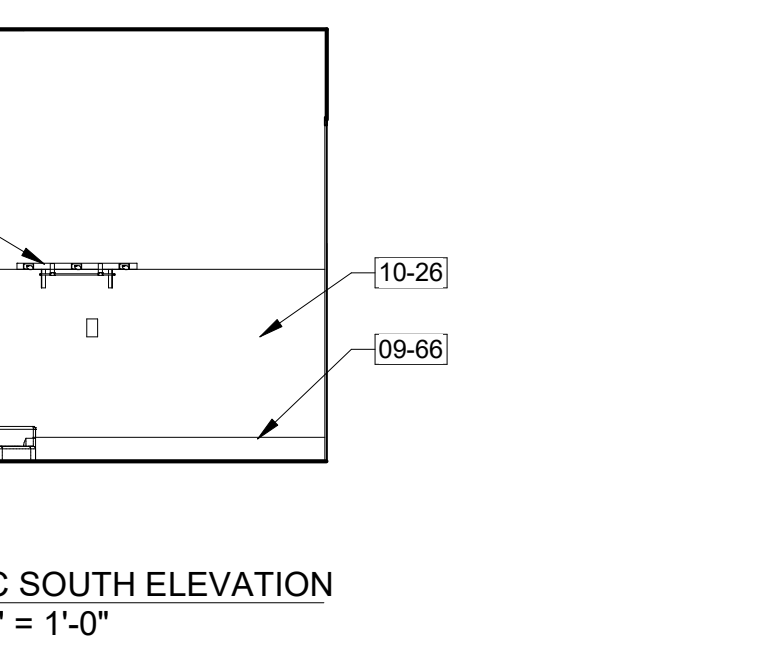
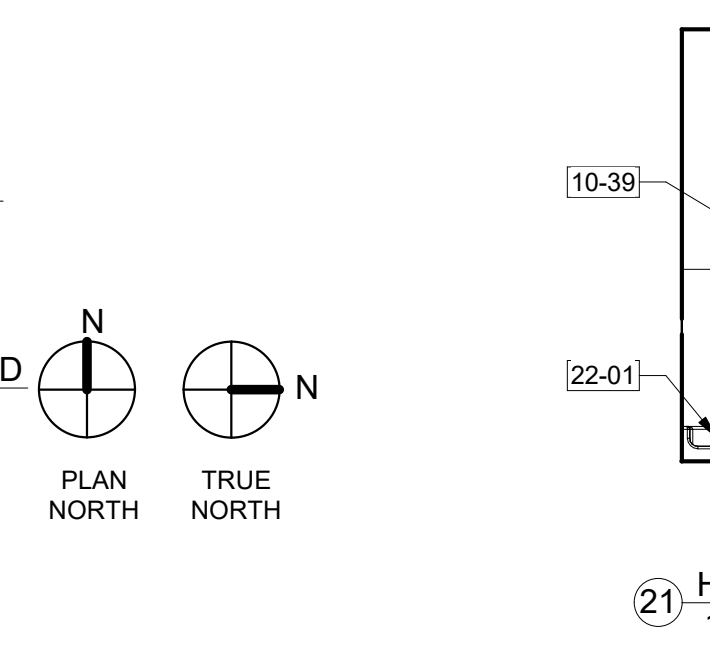
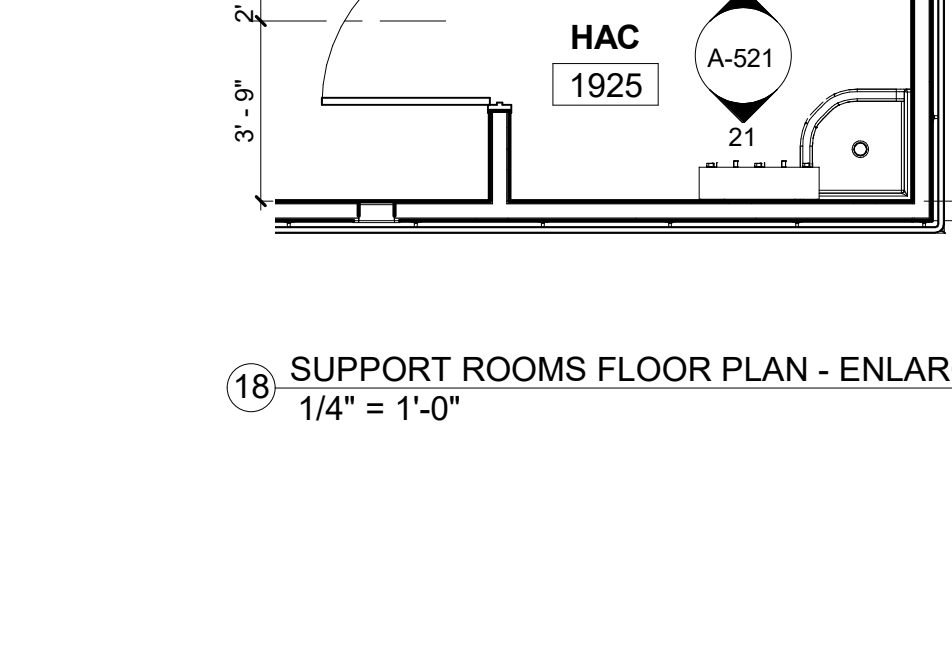
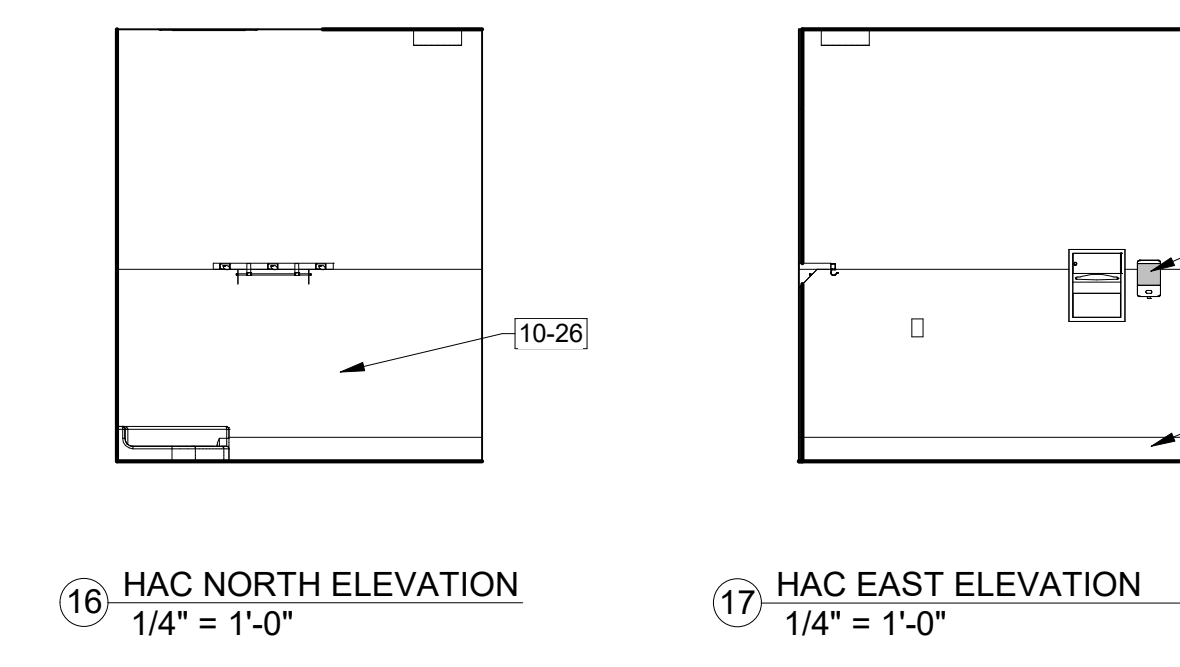
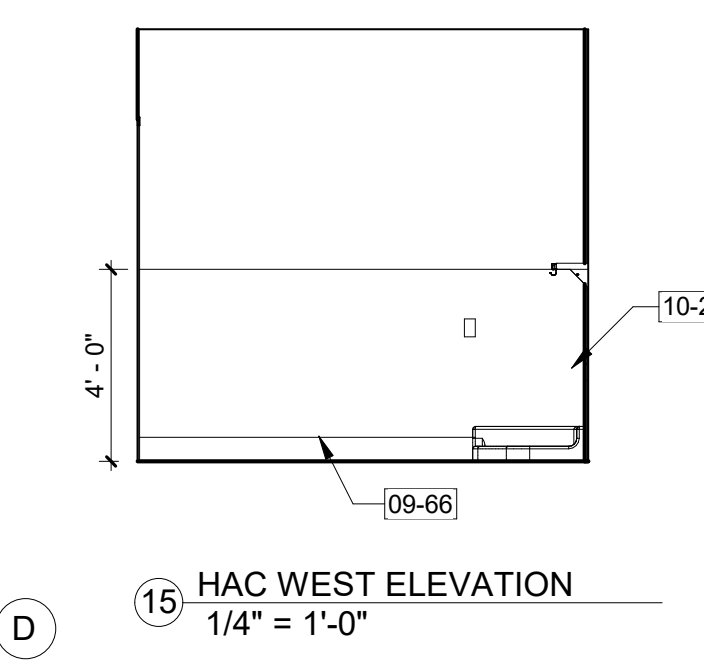
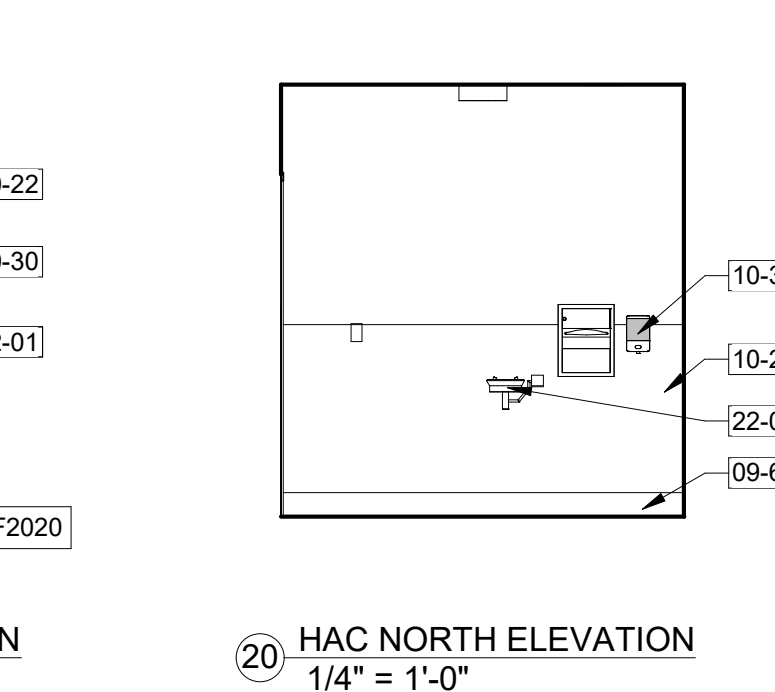
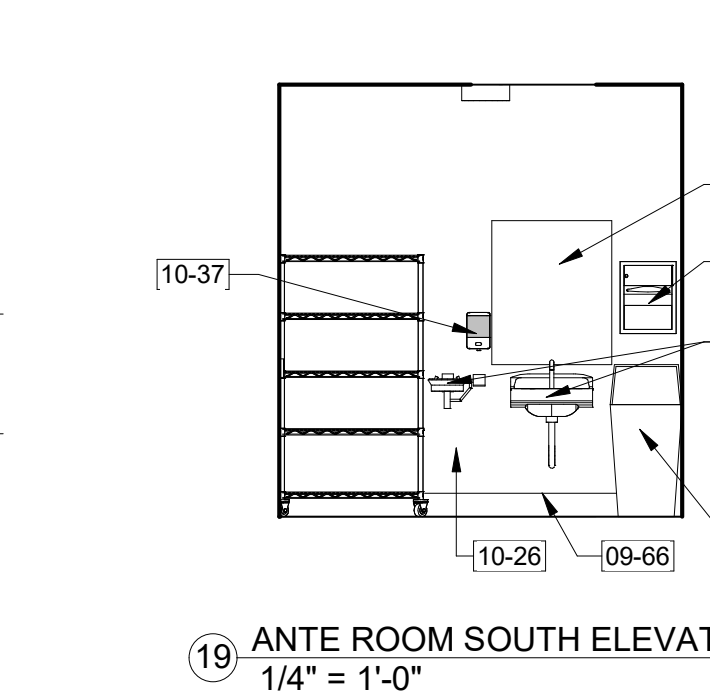
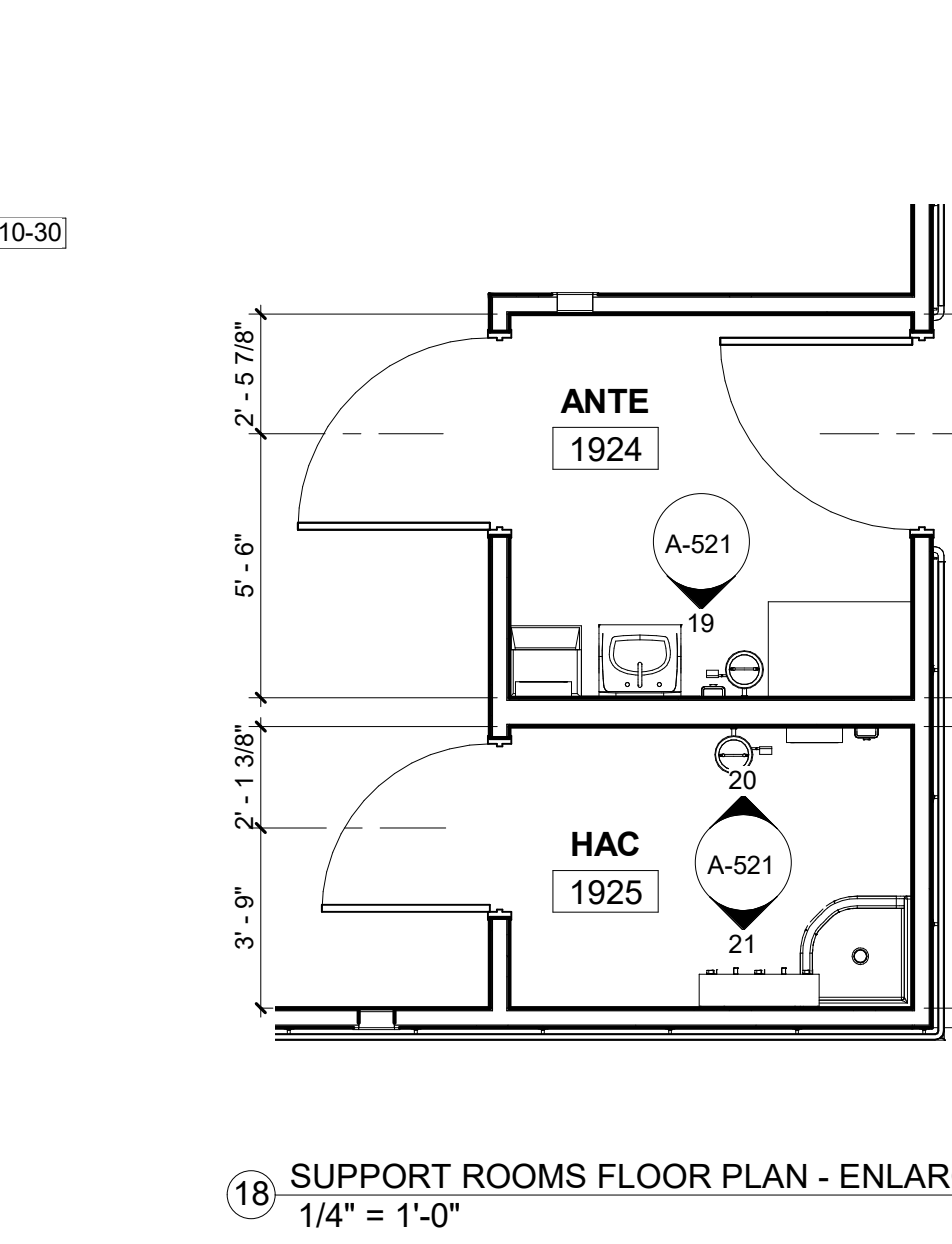
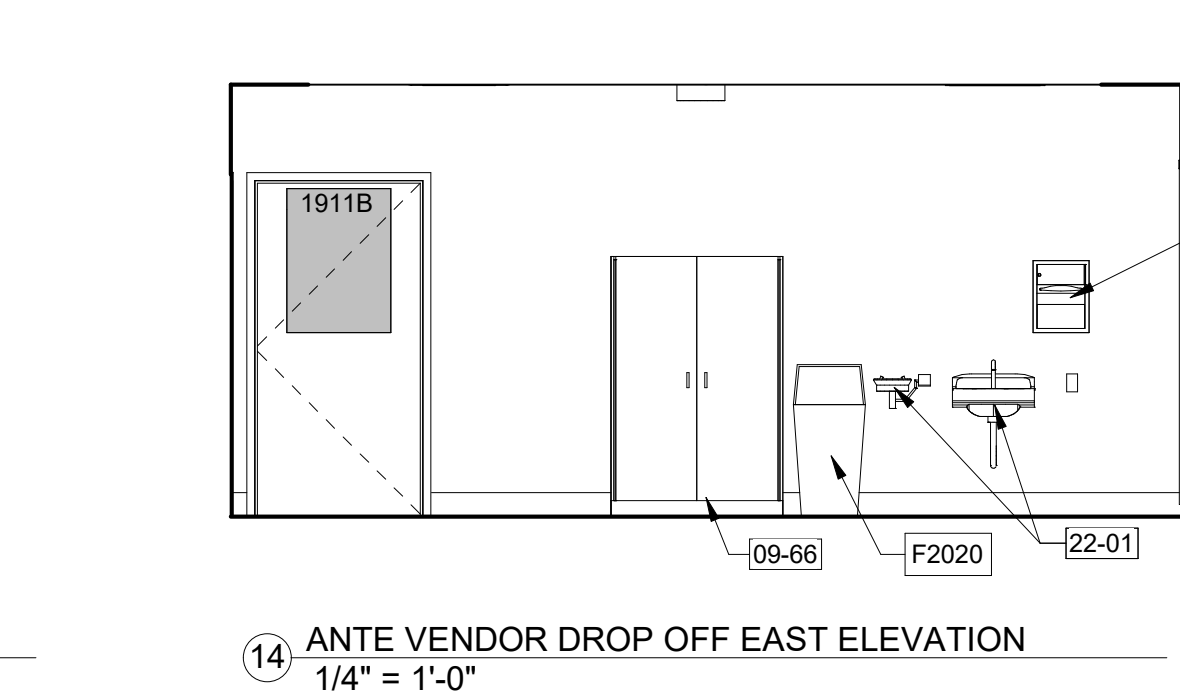
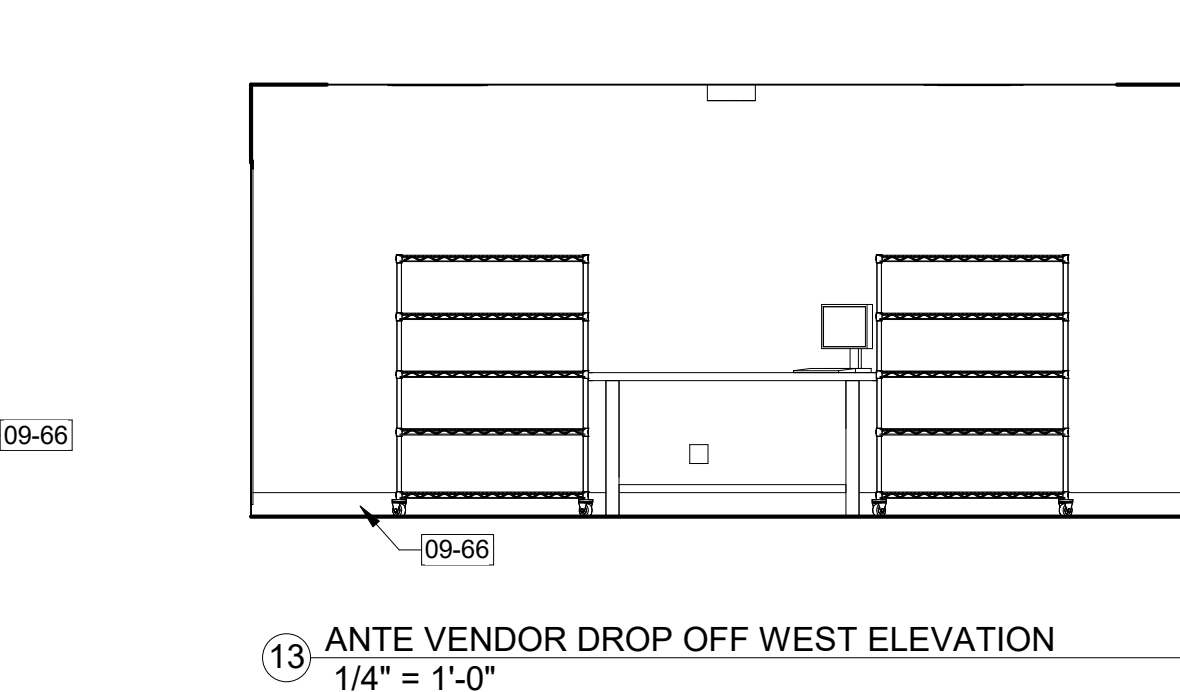
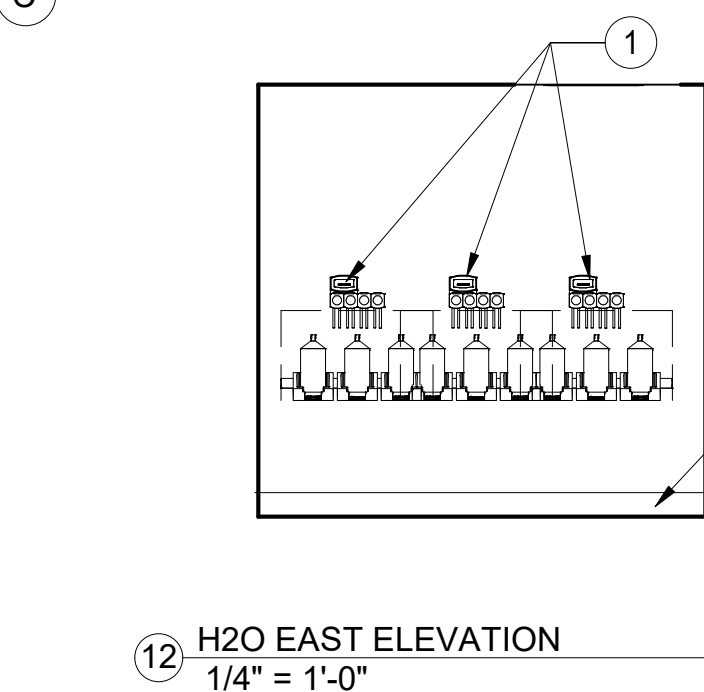
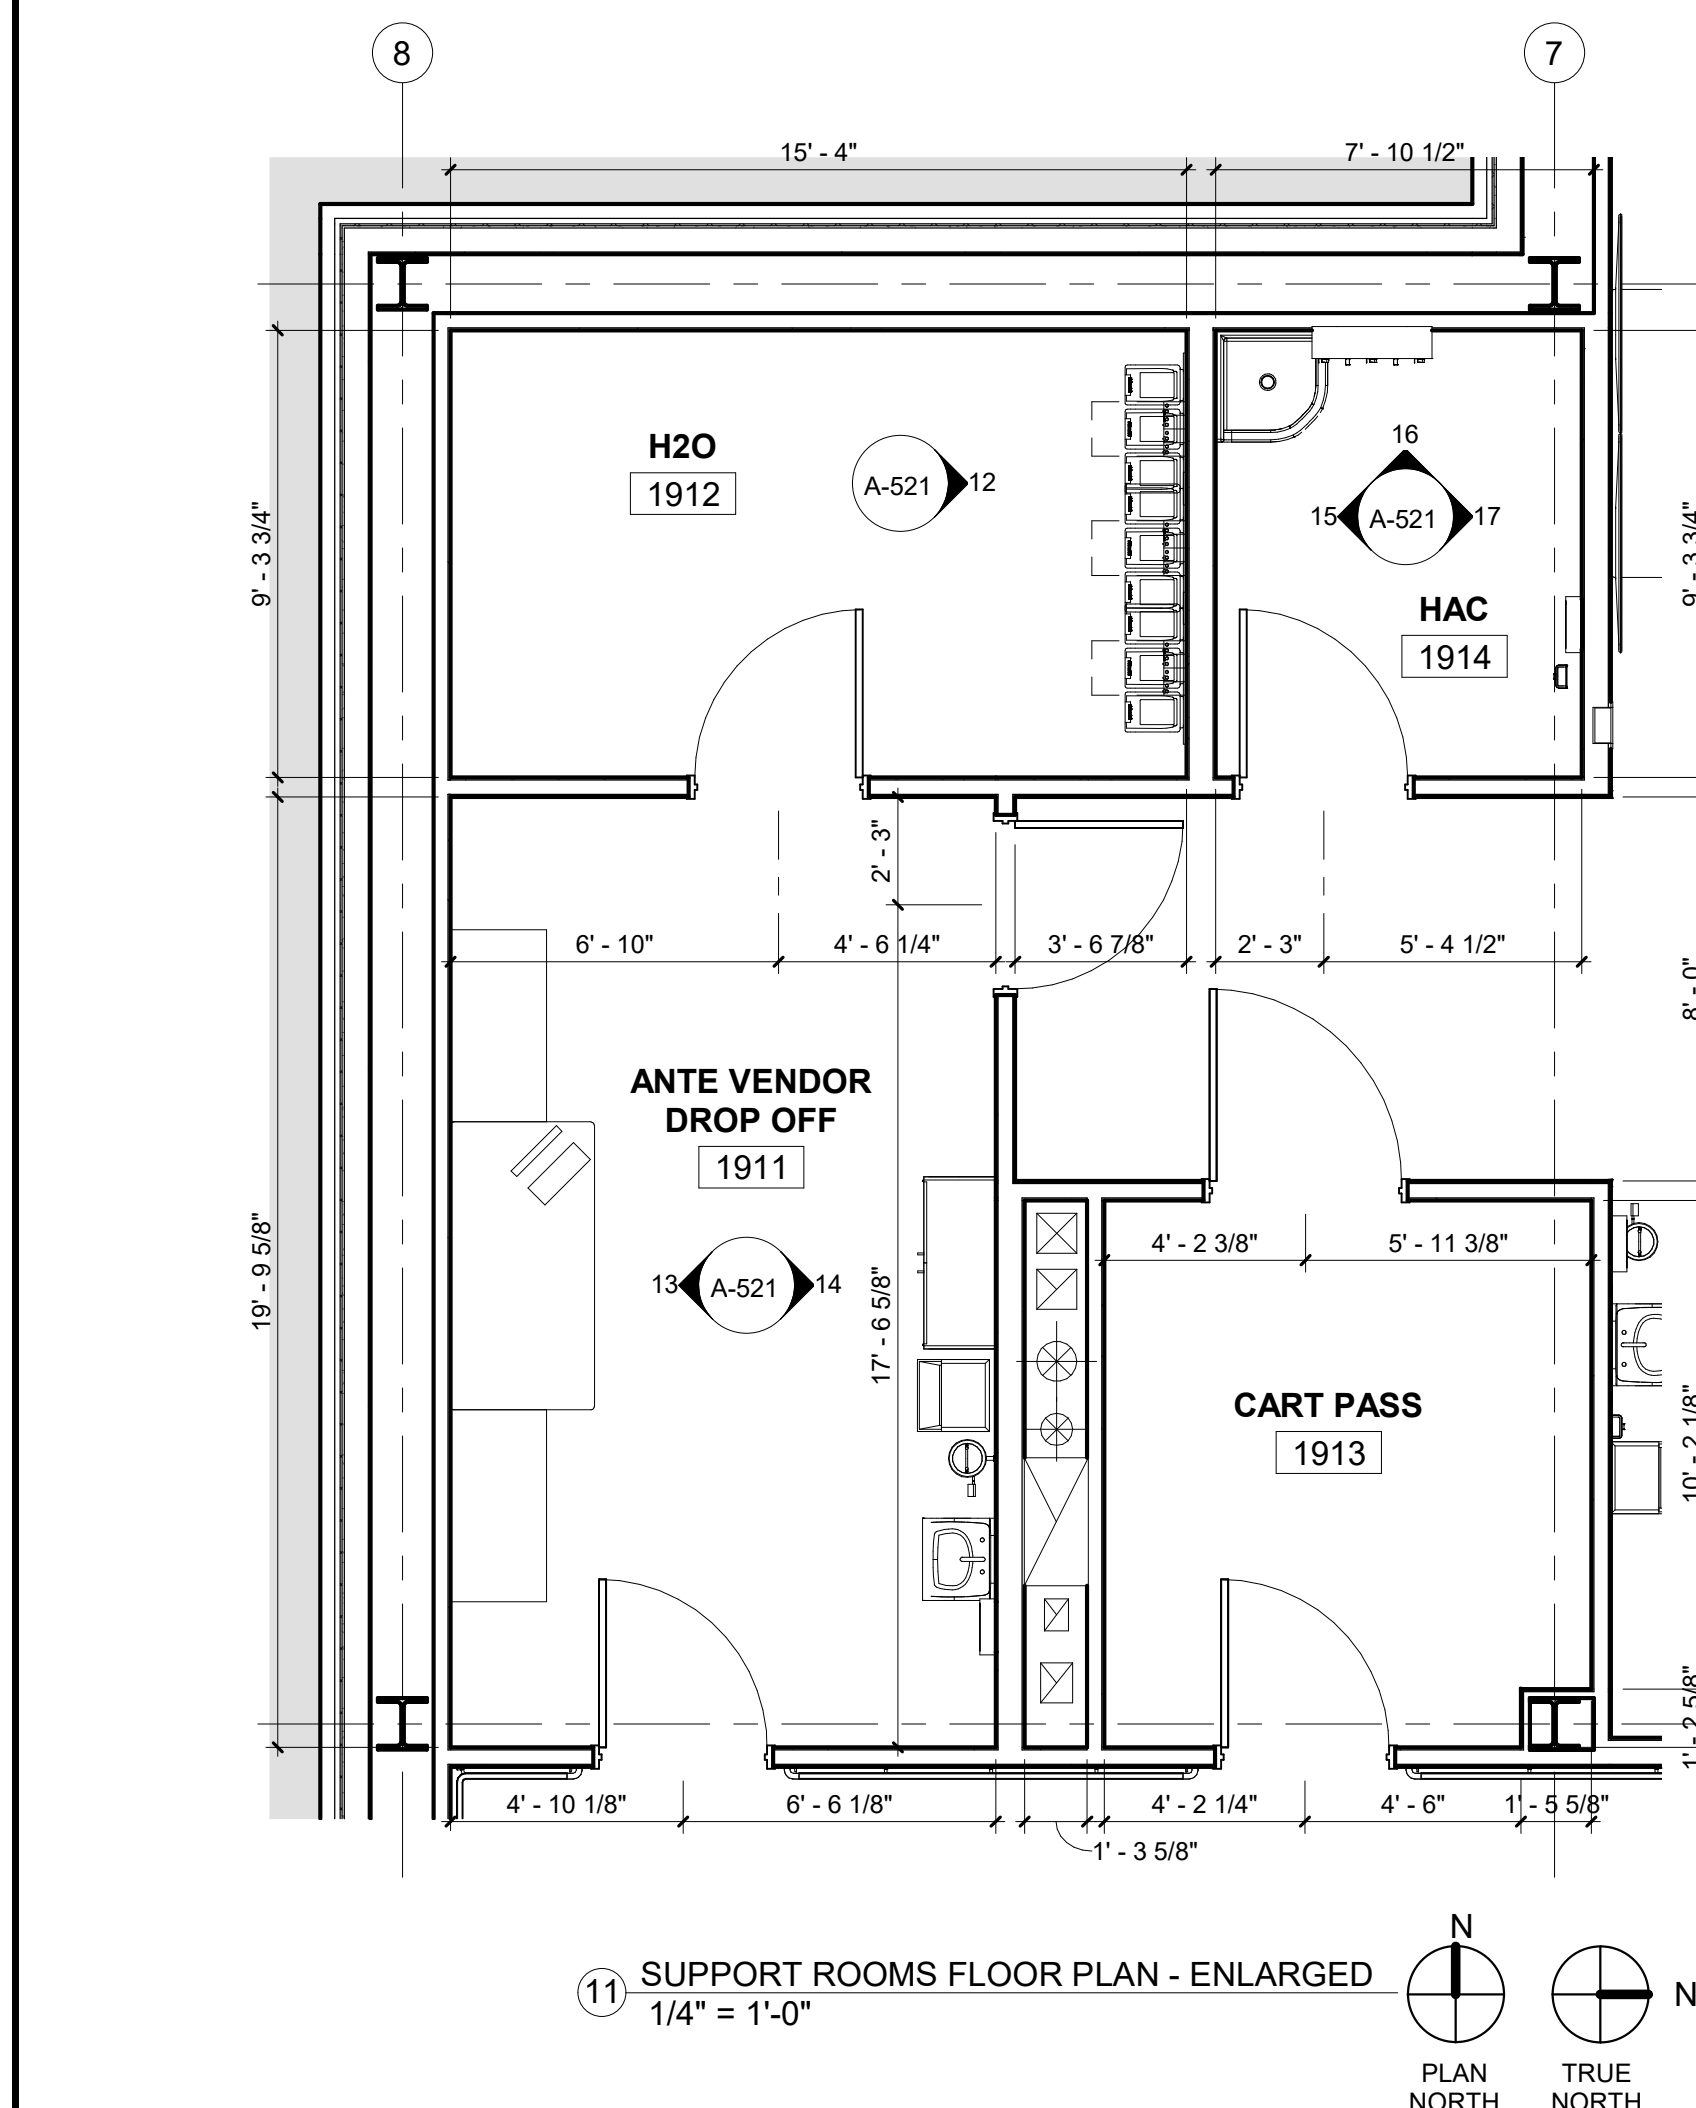
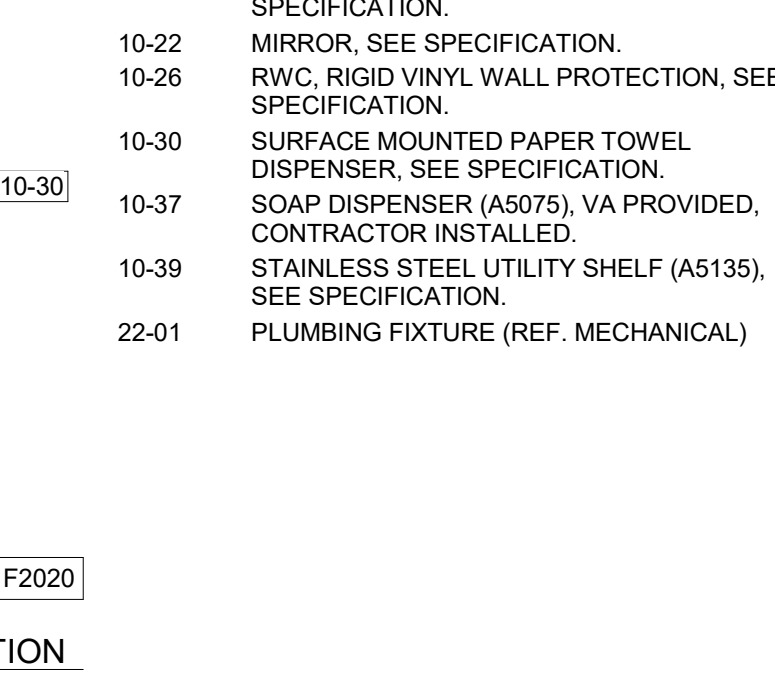
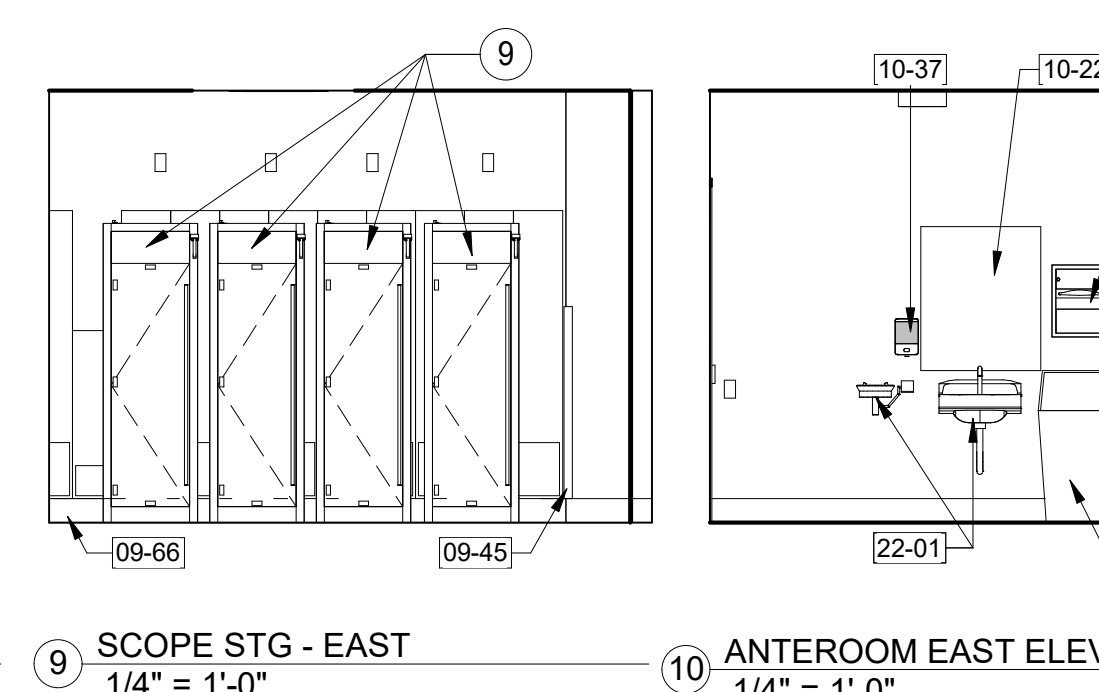
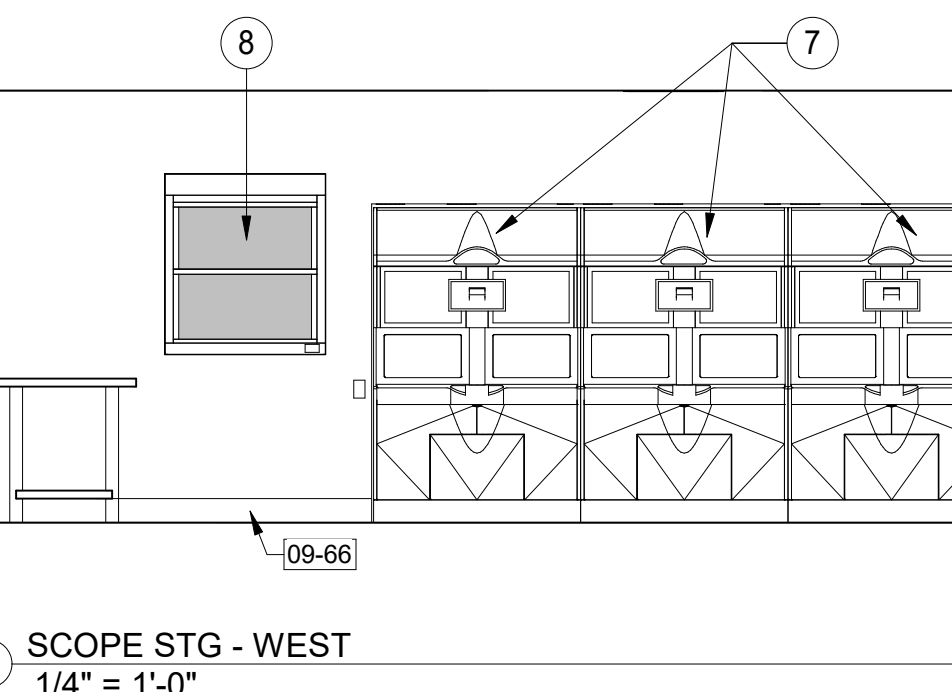
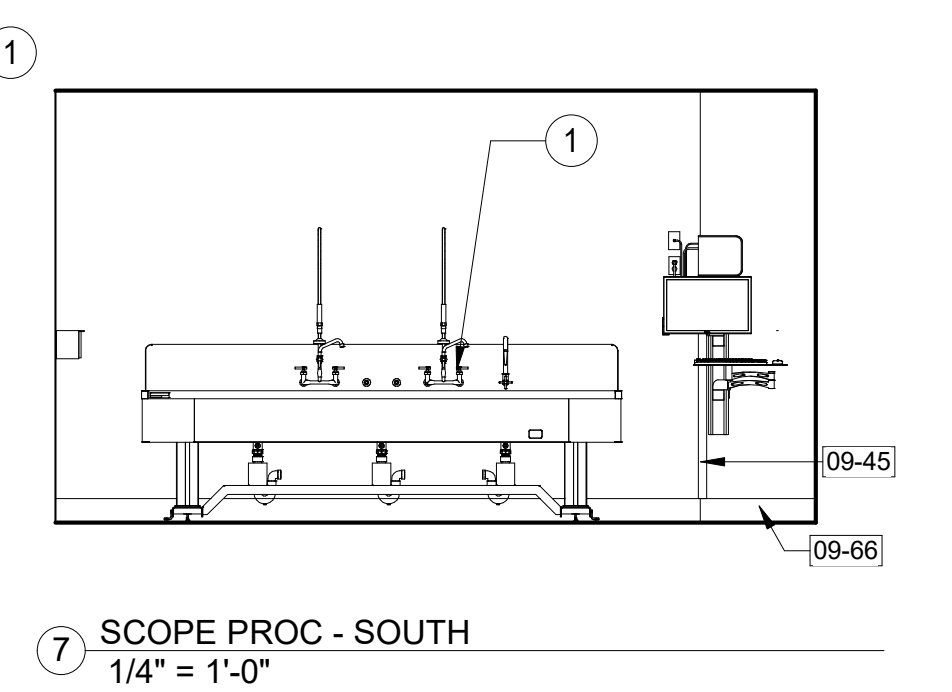
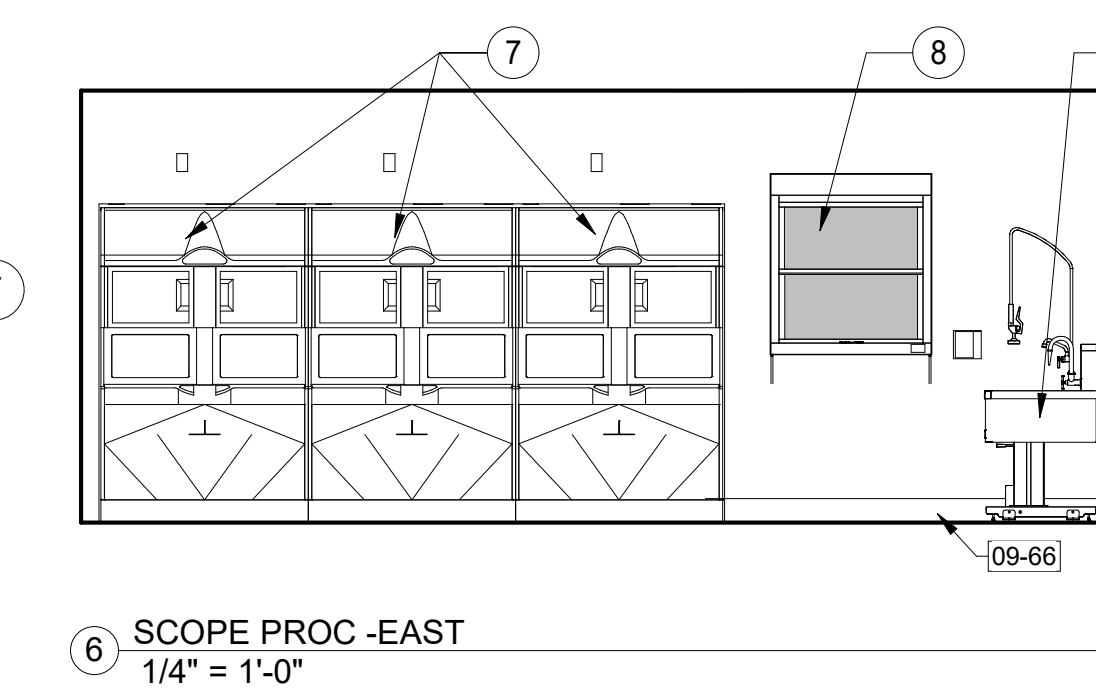
- SHEET SIZE FOR PROPER SCALE IS 30X42. CONTRACTOR SHALL NOT SCALE DRAWINGS BUT SHALL REQUEST THE DESIRED DIMENSIONS FROM THE ARCHITECT.
- SEE SHEET G-002 FOR GENERAL NOTES.
- APPLY 1 1/2" THICK FIREPROOFING AT ALL EXPOSED STEEL WITHIN INTERSTITIAL SPACE AND AT EXPOSED STEEL STRUCTURE ABOVE 3RD FLOOR CEILING, TYP.

SHEET SPECIFIC NOTES:

- BRING BOTTOM OF CORNER GUARDS 4" AFF.

KEYNOTES:

- 09-45 CORNER GUARD, SEE SPECIFICATION.
09-66 RES6, EPOXY FLOOR/COVE, SEE SPECIFICATION.
10-22 MIRROR, SEE SPECIFICATION.
10-26 RWC, RIGID VINYL WALL PROTECTION, SEE SPECIFICATION.
10-30 SURFACE MOUNTED PAPER TOWEL DISPENSER, SEE SPECIFICATION.
10-37 SOAP DISPENSER (A5075), VA PROVIDED, CONTRACTOR INSTALLED.
10-39 STAINLESS STEEL UTILITY SHELF (A5135), SEE SPECIFICATION.
22-01 PLUMBING FIXTURE (REF. MECHANICAL)



COMPLIANCY REVIEW INCLUDED	2/23/2024
Revisions:	Date

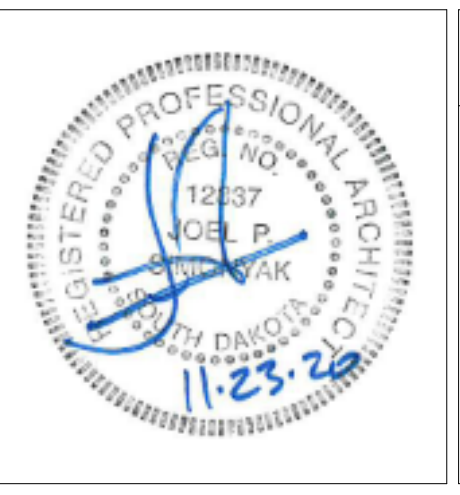
CONSULTANTS:

TERRASITE DESIGN
1635 DEADWOOD AVENUE
RAPID CITY, SOUTH DAKOTA 57702
PH: (605) 791-1736

Albertson Engineering Inc.

ALBERTSON ENGINEERING, INC.
315 NORTH MAIN AVENUE, SUITE 200
SIOUX FALLS, SOUTH DAKOTA 57104
PH: (605) 274-0880

FARRIS ENGINEERING
OMAHA (BRANCH) 1801 S. 182ND ST.
OMAHA, NEBRASKA 68154
PH: (402) 330-5900



ARCHITECT

FOURFRONT DESIGN, INC.
517 7TH STREET
RAPID CITY, SOUTH DAKOTA 57701
PH: (605) 342-9470
FAX: (605) 342-2377
WWW.FOURFRONTDESIGN.COM

Drawing Title	ENLARGED PLANS AND INTERIOR ELEVATIONS
Approved: Project Director	Omaha VA Medical Center

Project Title	Design/Construct Sterile Processing Service- Omaha VA Medical Center
Location	4101 Woolworth Ave #4199 Omaha, Ne 68105
Date	11/23/2020
Checked	JL
Drawn	JGC

Project Number	16.2330.A08
Building Number	25
Drawing Number	A-521
Dwg. 73 of 193	

Office of Construction and Facilities Management
Department of Veterans Affairs

CONSTRUCTION DOCUMENTS

GENERAL NOTES:

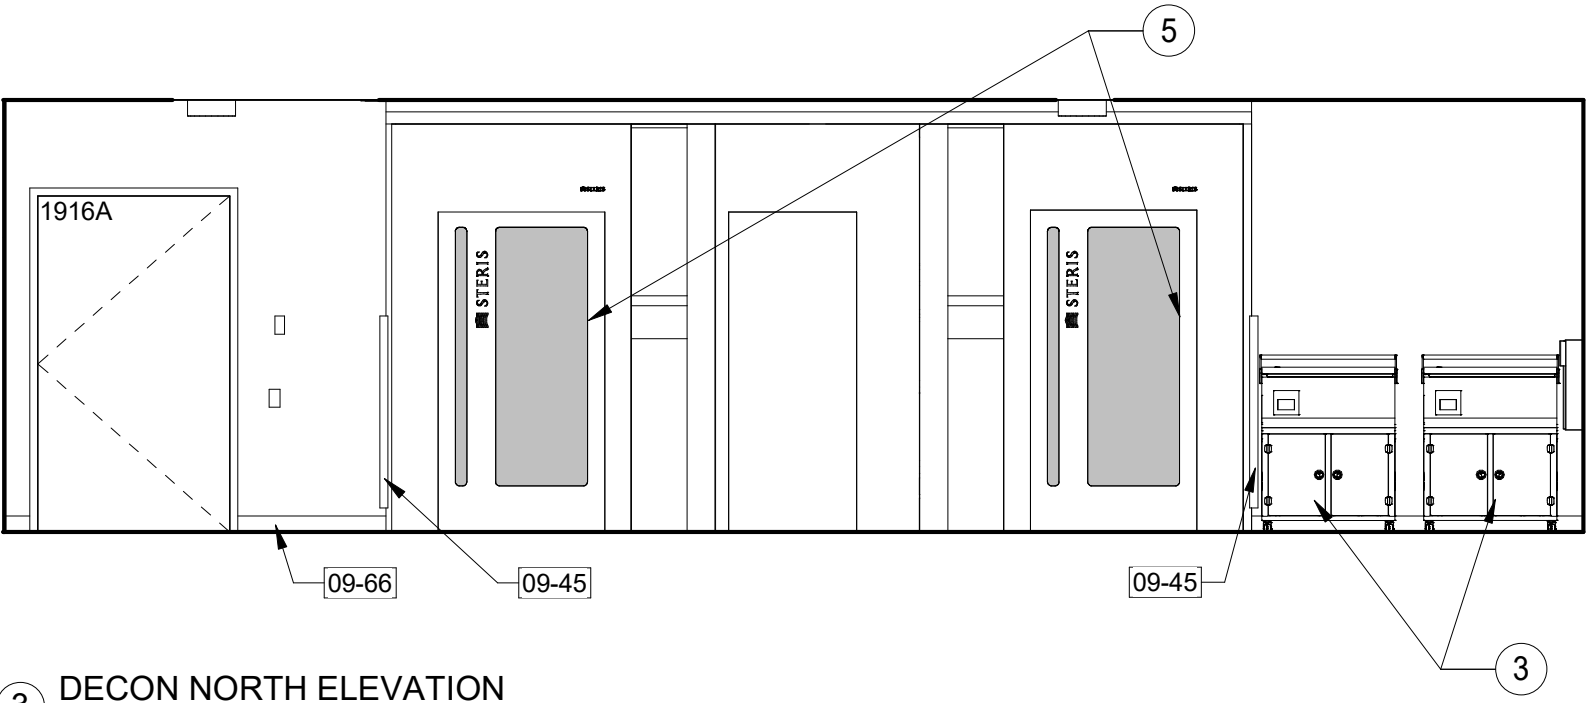
- SHEET SIZE FOR PROPER SCALE IS 30X42. CONTRACTOR SHALL NOT SCALE DRAWINGS BUT SHALL REQUEST THE DESIRED DIMENSIONS FROM THE ARCHITECT.
- IT IS THE RESPONSIBILITY OF THE CONTRACTOR TO FIELD VISIT THE PROJECT AND VERIFY EXISTING CONDITIONS, DIMENSIONS AND PROPOSED CONDITIONS. COORDINATE DEMOLITION BETWEEN ALL TRADES. NOTIFY A/E IMMEDIATELY OF ANY CONFLICTS OR DISCREPANCIES.
- GRID LINES ARE TYPICALLY LOCATED ON THE FACE OF FOUNDATION OR CENTERLINE OF STRUCTURE.
- WALL PARTITIONS EXTEND TO THE UNDERSIDE OF DECK UNLESS NOTED WITH WALL HEIGHT NEXT TO WALL TYPE TAG.
- SEE ENLARGED AREA PLANS FOR WALL TYPE INDICATIONS AND DIMENSIONS.
- SEE CODE PLAN FOR CODE INFORMATION.
- SEE DIMENSION PLAN FOR DIMENSIONS AND WALL TYPES.
- EXISTING DOORS SHOW AT 45 DEGREE ANGLE FOR CLARITY WITH THE EXCEPTION OF TOILET PARTITIONS.
- EXISTING WALL SHADED FOR CLARITY.
- SYSTEMS FURNISHINGS AND OWNER PROVIDED CONTRACTOR INSTALLED ITEMS NOT SHOWN FOR CLARITY. SEE FF&E PLANS.

SHEET SPECIFIC NOTES:


- BRING BOTTOM OF CORNER GUARDS 4" AFF.

KEYNOTES:


- 09-45 CORNER GUARD, SEE SPECIFICATION.
09-65 RB-1, RUBBER BASE, SEE SPECIFICATION.
09-66 RES6, EPOXY FLOOR/COVE, SEE SPECIFICATION.
10-22 MIRROR, SEE SPECIFICATION.
10-26 RWC, RIGID VINYL WALL PROTECTION, SEE SPECIFICATION.
10-30 SURFACE MOUNTED PAPER TOWEL DISPENSER, SEE SPECIFICATION.
10-37 SOAP DISPENSER (A5075), VA PROVIDED, CONTRACTOR INSTALLED.
10-40 FIRE EXTINGUISHER CABINET.
11-30 REFRIGERATOR BY OWNER, TYP. (N.I.C. - REF. ELECTRICAL).
12-35 PL-1, PLASTIC LAMINATE WALL CABINETS, TYP., SEE SPECIFICATION.
12-41 QUARTZ COUNTERTOP, EASED EDGE.
12-42 PL-1, PLASTIC LAMINATE WALL CABINETS, TYP., SEE SPECIFICATION.
22-01 PLUMBING FIXTURE (REF. MECHANICAL).
26-02 ELECTRICAL EQUIPMENT (REFERENCE ELECTRICAL).




3 DECON NORTH ELEVATION
1/4" = 1'-0"

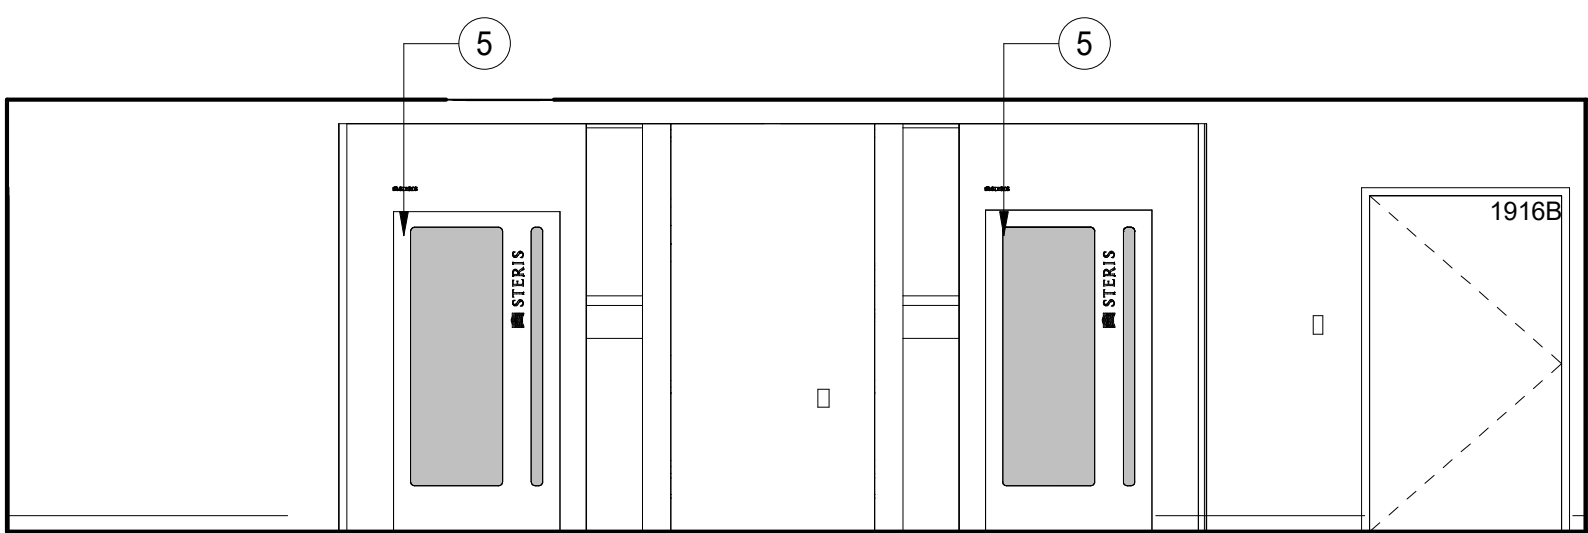


6 CART DRY SOUTH ELEVATION
1/4" = 1'-0"

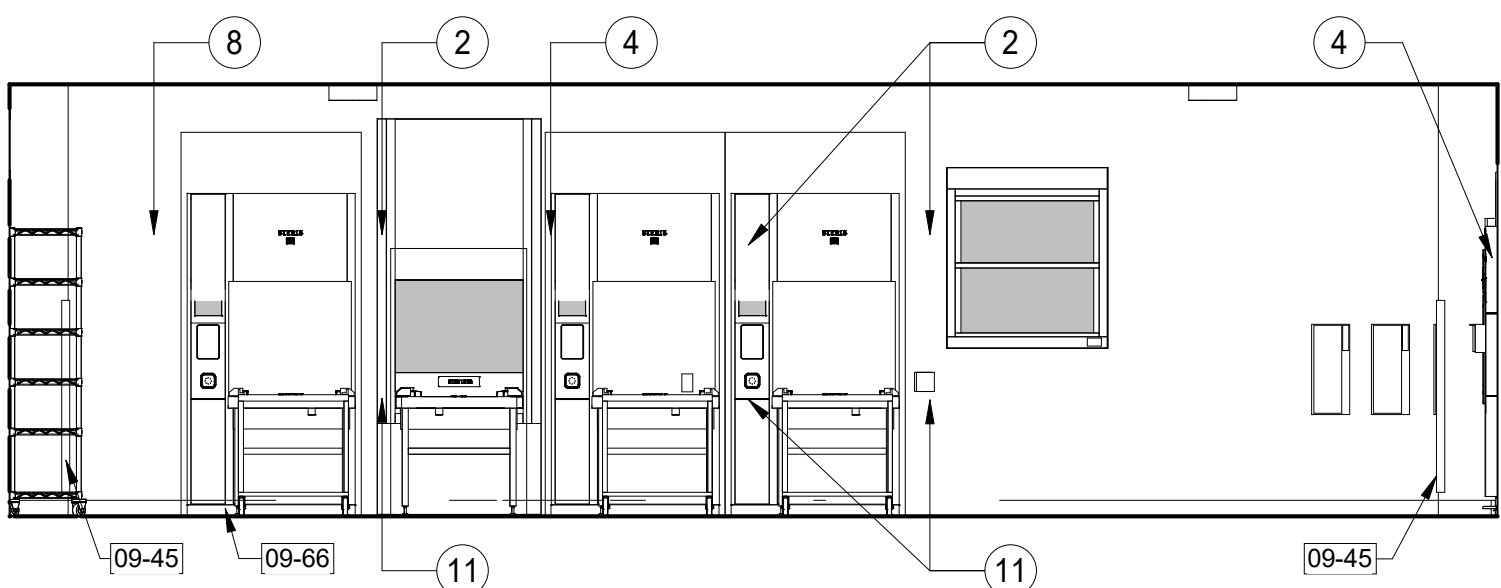

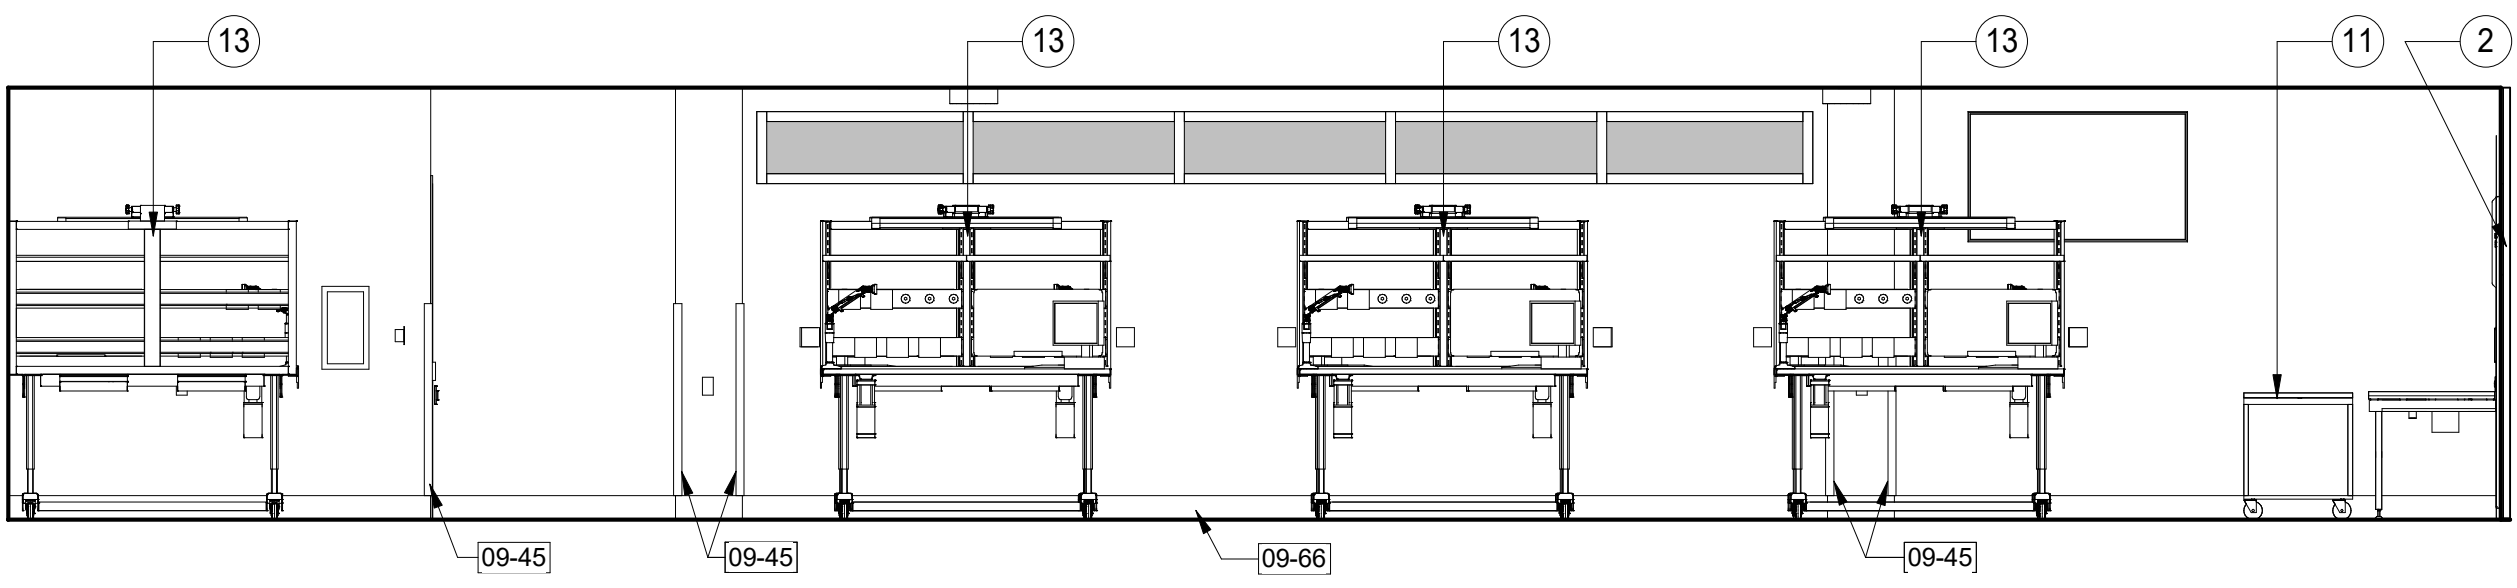
9 PREP ASSEMBLY WEST ELEVATION
1/4" = 1'-0"



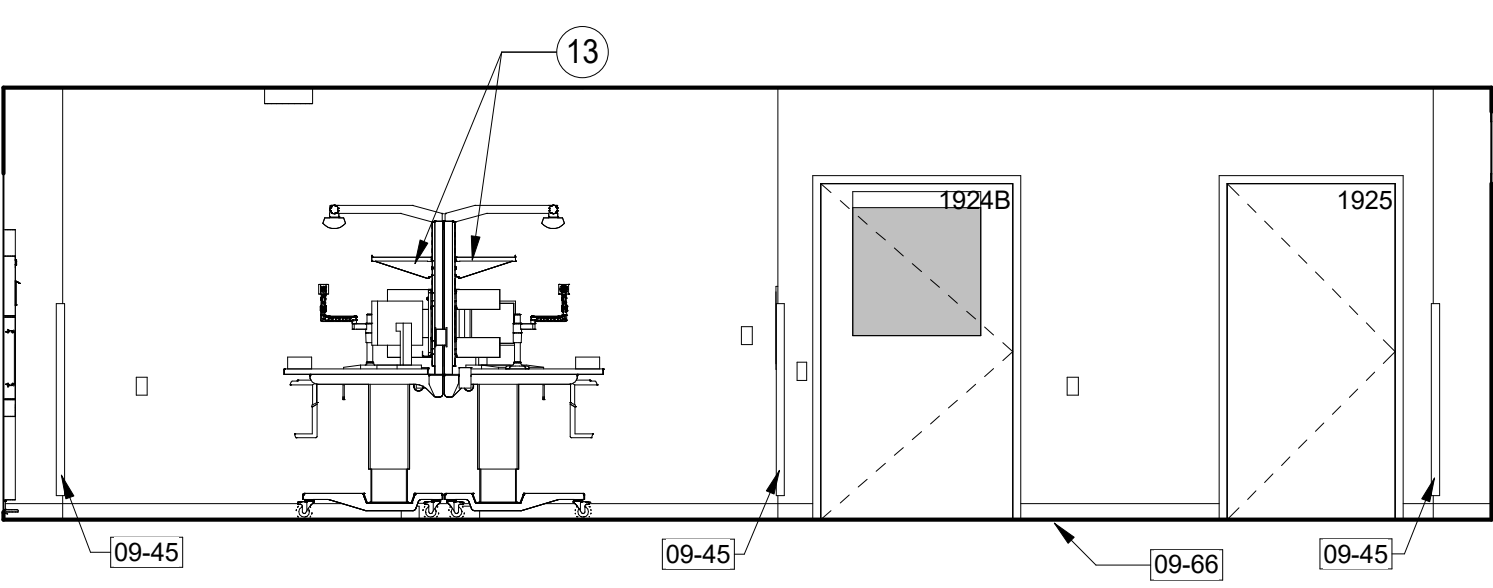
12 PREP ASSEMBLY SOUTH ELEVATION
1/4" = 1'-0"



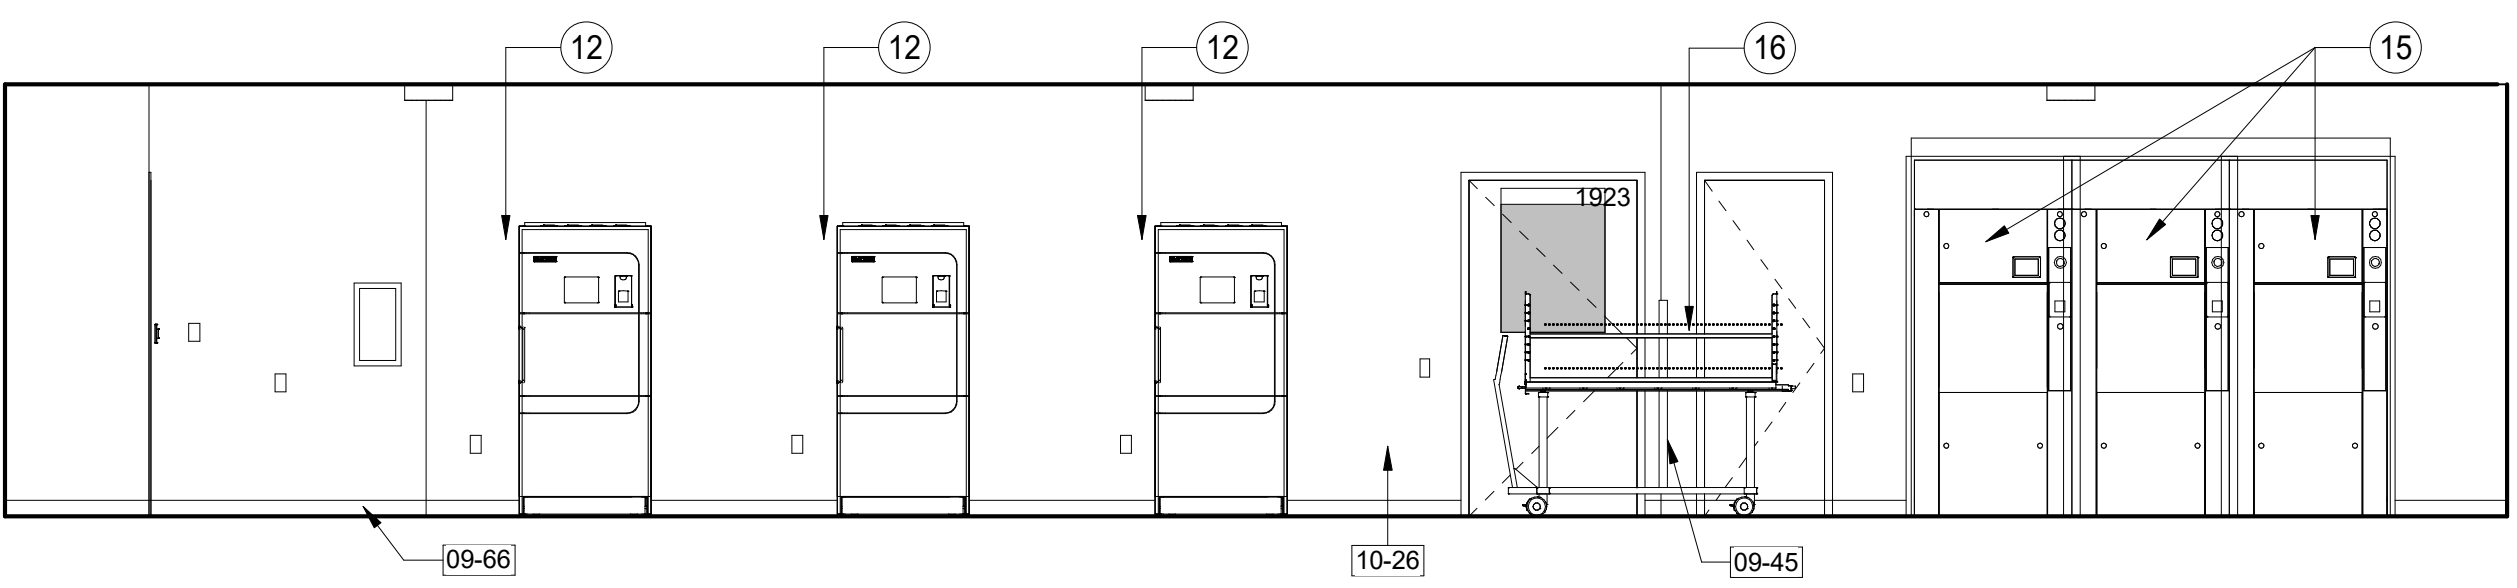
11 PREP ASSEMBLY EAST ELEVATION
1/4" = 1'-0"



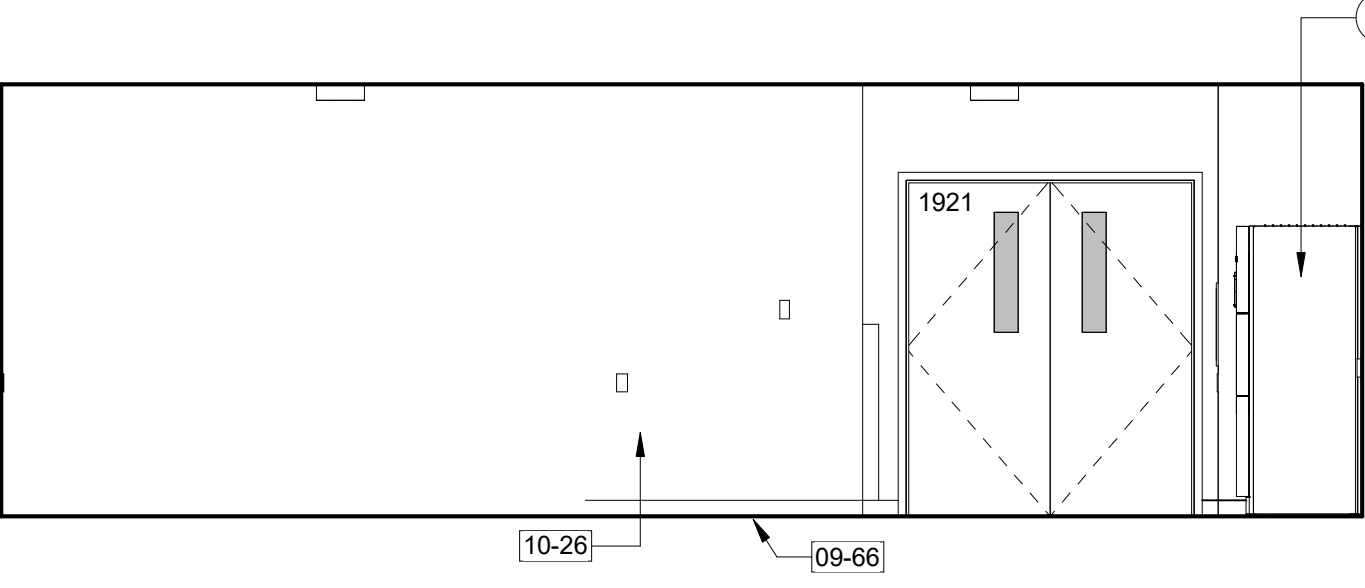
8 STERILIZATION SOUTH ELEVATION
1/4" = 1'-0"



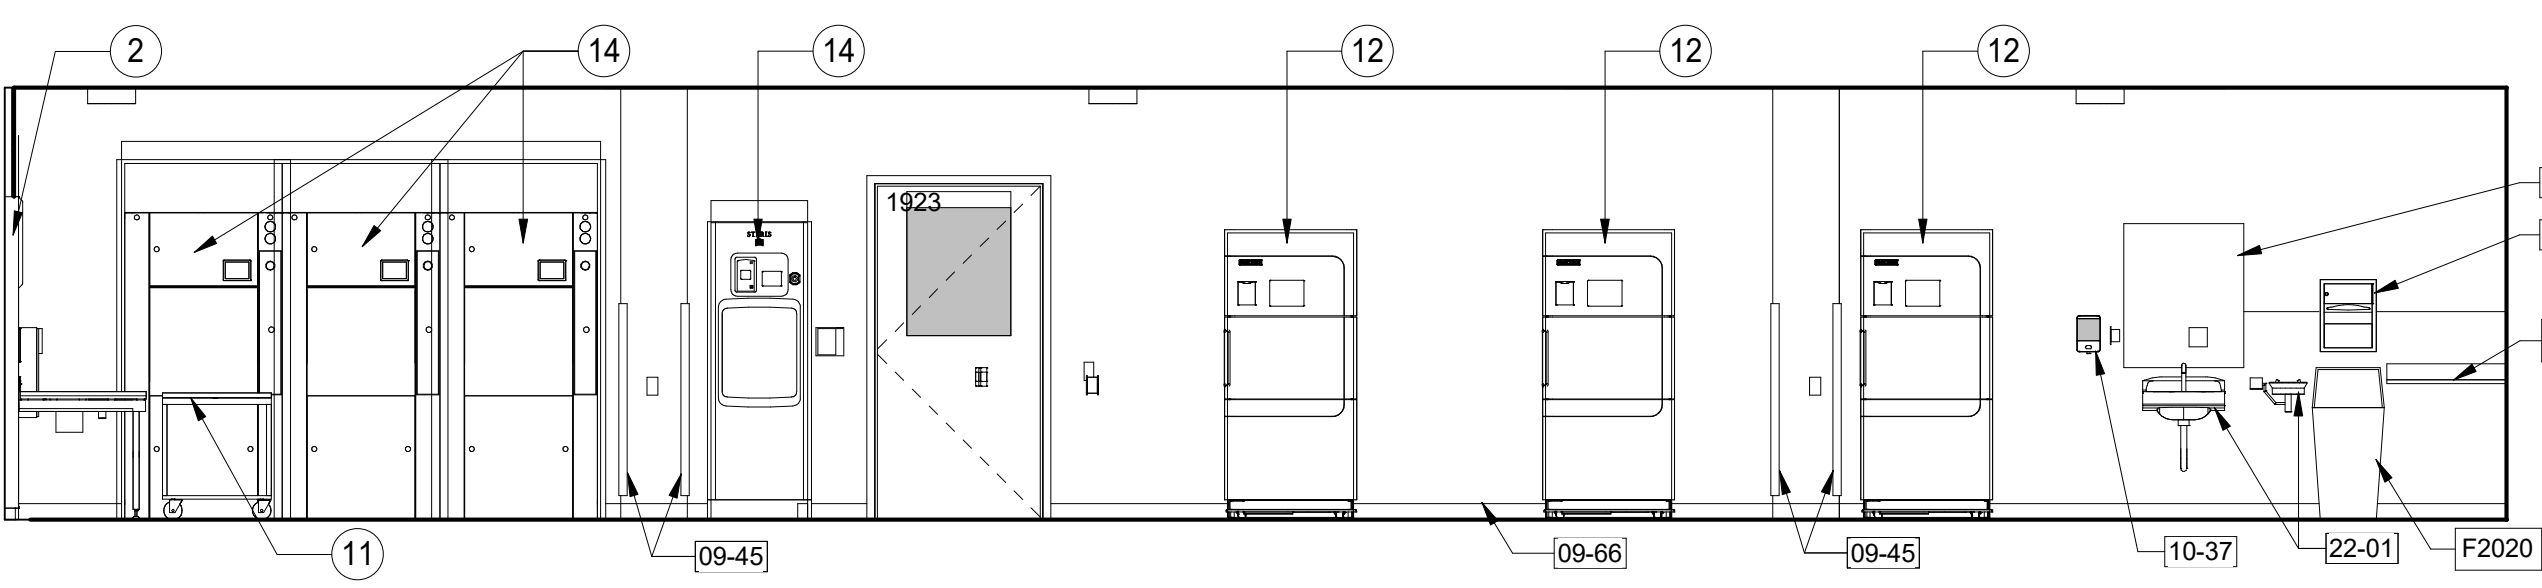
7 STERILIZATION EAST ELEVATION
1/4" = 1'-0"



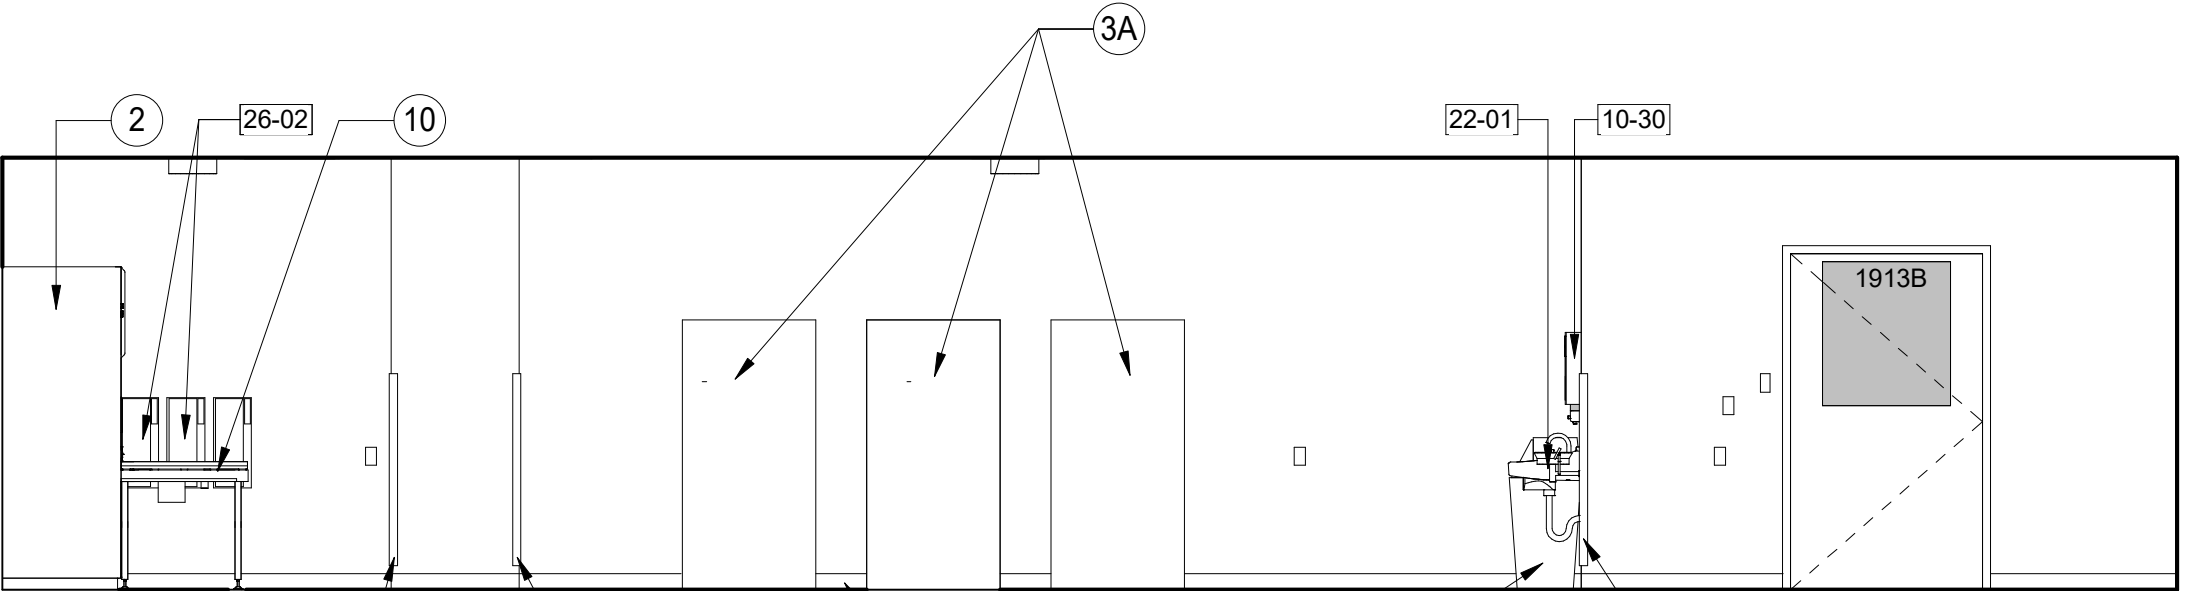
10 PREP ASSEMBLY NORTH ELEVATION
1/4" = 1'-0"




5 DECON SOUTH ELEVATION
1/4" = 1'-0"

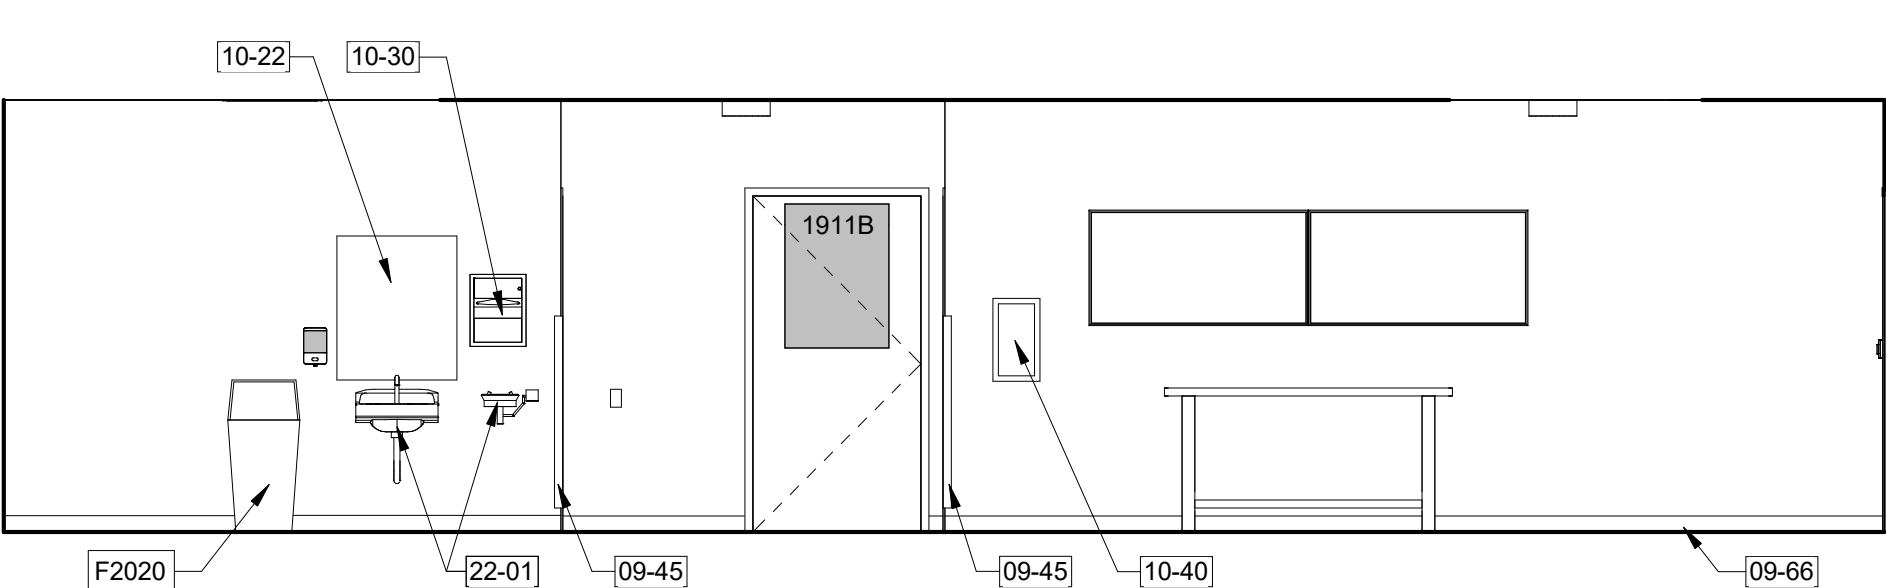

2 DECON WEST ELEVATION
1/4" = 1'-0"

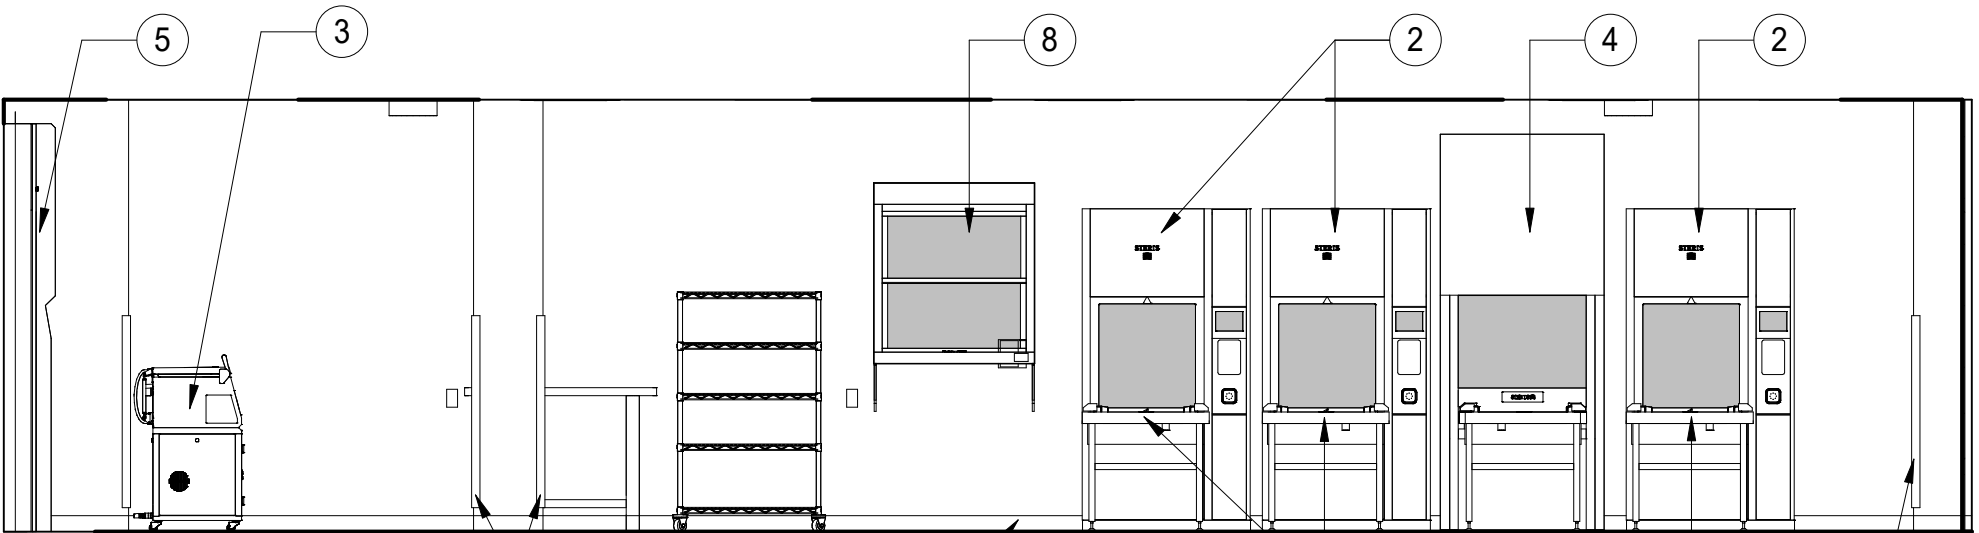

4 DECON EAST ELEVATION
1/4" = 1'-0"

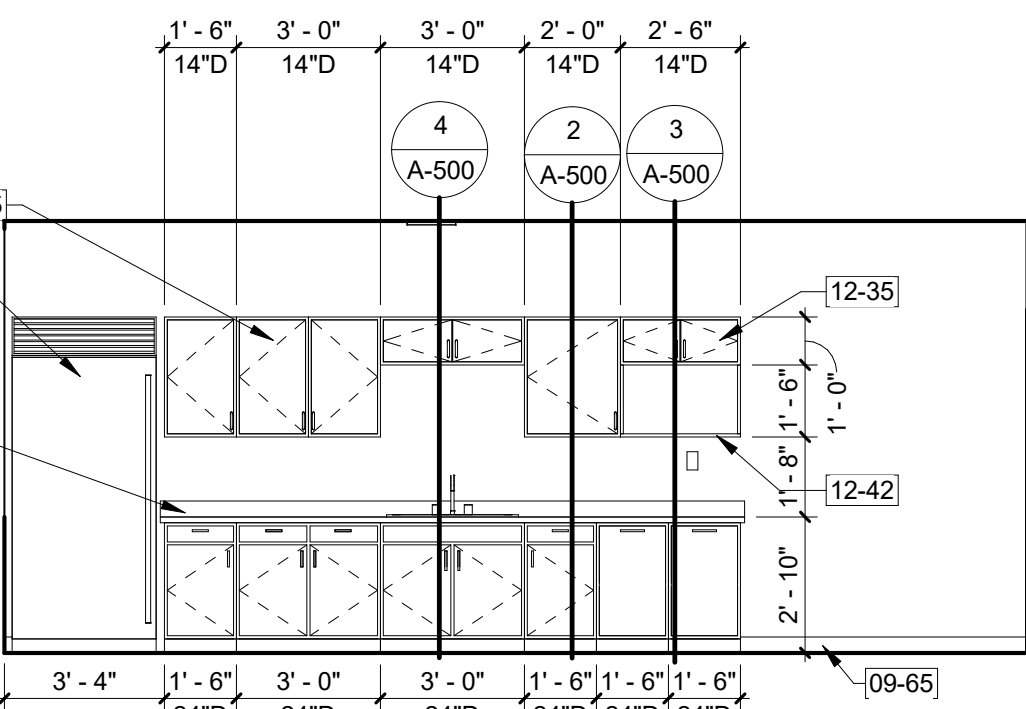


1 BREAK ROOM WEST ELEVATION
1/4" = 1'-0"

CONSTRUCTION DOCUMENTS

CONSULTANTS: TERRASITE DESIGN 1635 DEADWOOD AVENUE RAPID CITY, SOUTH DAKOTA 57702 PH: (605) 791-1736 ALBERTSON ENGINEERING, INC. 315 NORTH MAIN AVENUE, SUITE 200 SIOUX FALLS, SOUTH DAKOTA 57104 PH: (605) 274-0880 FARRIS ENGINEERING OMAHA (BRANCH) 30101 12700 WEST DODGE ROAD OMAHA, NEBRASKA 68154 PH: (402) 330-5900		ARCHITECT FOURFRONT DESIGN, INC. 517 7TH STREET RAPID CITY, SOUTH DAKOTA 57701 PH: (605) 342-9470 FAX: (605) 342-2377 WWW.FOURFRONTDESIGN.COM		Drawing Title INTERIOR ELEVATIONS Approved: Project Director Omaha VA Medical Center		Project Title Design/Construct Sterile Processing Service- Omaha VA Medical Center Location 4101 Woolworth Ave #4199 Omaha, Ne 68105 Date 11/23/2020 Checked JL Drawn JGC		Project Number 16.2330.A08 Building Number 25 Drawing Number A-522 Dwg. 74 of 193		Office of Construction and Facilities Management Department of Veterans Affairs	
---	--	---	--	--	--	---	--	--	--	---	--

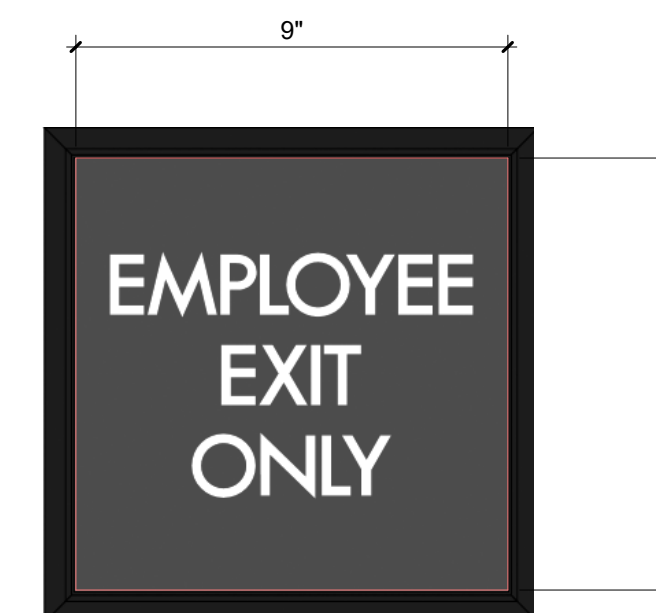Signage Schedule




1. SHEET SIZE FOR PROPER SCALE IS 30X42.
2. CONTRACTOR SHALL NOT SCALE DRAWINGS BUT SHALL REQUEST THE DESIRED DIMENSIONS FROM THE ARCHITECT.
3. IT IS THE RESPONSIBILITY OF THE CONTRACTOR TO HAVE THE PROJECT MEASURED FOR ALL EXISTING CONDITIONS/DIMENSIONS AND DEMOLITION CONDITIONS. COORDINATE DEMOLITION BETWEEN ALL TRADES. NOTIFY ALL TRADES OF ALL COLLISIONS, CONFLICTS OR DISCREPANCIES.
4. GRIDLINES ARE TYPICALLY LOCATED ON THE FACE OF THE CONCRETE DECK.
5. WALL PARTITIONS EXTEND TO THE UNDERSIDE OF DECK UNLESS NOTED WITH WALL HEIGHT NEXT TO THE GRID TYPE.
6. SEE ENLARGED AREA PLANS FOR WALL TYPE INDICATIONS AND DIMENSIONS.
7. SEE CODE FOR AN EGRESS REQUIREMENT.
8. SEE DIMENSION PLAN FOR DIMENSIONS AND WALL PARTITIONS.
9. EXISTING DOORS SHOW AT 45 DEGREE ANGLE FOR CLARITY WITH THE EXCEPTION OF TOILET PARTITIONS.
10. EXISTING WALL SHADED FOR CLARITY.
11. SYSTEMS FURNISHINGS AND OWNER PROVIDED EQUIPMENT FOR INSTALLED ITEMS NOT SHOWN FOR CLARITY. SEE FF&E PLANS.

1. SEE SPECIFICATIONS FOR FINISHES AND BASIS OF DESIGN OMAHA VA SIGN STANDARDS.
2. WHERE PERMANENT IDENTIFICATION IS PROVIDED FOR ROOMS AND SPACES, SIGNS SHALL BE INSTALLED ON THE WALL ADJACENT TO THE LATCH SIDE OF THE DOOR. WHERE THERE IS NO WALL SPACE TO THE LATCH SIDE OF THE DOOR, INCLUDING AT DOUBLE LEAF DOORS, SIGNS SHALL BE PLACED ON THE NEAREST ADJACENT WALL. FINISHING HEIGHT SHALL BE 5' 0" TO 5' 6" ABOVE THE FINISH FLOOR TO THE CENTERLINE OF THE SIGN. WALL MOUNTED TYPE H AND I SIGNS TO BE MOUNTED 80" AFF TO BOTTOM OF SIGN.

18/2023 1:44:50 PM


	F	E	D	C	B	A
one eighth inch = one foot	0 4 8 16	0 4 8	0 4	0 2 4 6	0 2 4 6	0 1 2 3 4 5 6
one quarter inch = one foot	0 4 8	0 4	0 4	0 2 4 6	0 2 4 6	0 1 2 3 4 5 6
three eighths inch = one foot	0 4 8	0 4	0 4	0 2 4 6	0 2 4 6	0 1 2 3 4 5 6
one half inch = one foot	0 4	0 4	0 4	0 2 4 6	0 2 4 6	0 1 2 3 4 5 6
one inch = one foot	0 4	0 4	0 4	0 2 4 6	0 2 4 6	0 1 2 3 4 5 6
one and one half inches = one foot	0 4 8 16	0 4 8	0 4	0 2 4 6	0 2 4 6	0 1 2 3 4 5 6
two inches = one foot	0 4 8	0 4	0 4	0 2 4 6	0 2 4 6	0 1 2 3 4 5 6
two and one half inches = one foot	0 4 8 16	0 4 8	0 4	0 2 4 6	0 2 4 6	0 1 2 3 4 5 6
three inches = one foot	0 4 8	0 4	0 4	0 2 4 6	0 2 4 6	0 1 2 3 4 5 6
three and one half inches = one foot	0 4 8 16	0 4 8	0 4	0 2 4 6	0 2 4 6	0 1 2 3 4 5 6
four inches = one foot	0 4 8	0 4	0 4	0 2 4 6	0 2 4 6	0 1 2 3 4 5 6
four and one half inches = one foot	0 4 8 16	0 4 8	0 4	0 2 4 6	0 2 4 6	0 1 2 3 4 5 6
five inches = one foot	0 4 8	0 4	0 4	0 2 4 6	0 2 4 6	0 1 2 3 4 5 6
five and one half inches = one foot	0 4 8 16	0 4 8	0 4	0 2 4 6	0 2 4 6	0 1 2 3 4 5 6
six inches = one foot	0 4 8	0 4	0 4	0 2 4 6	0 2 4 6	0 1 2 3 4 5 6
six and one half inches = one foot	0 4 8 16	0 4 8	0 4	0 2 4 6	0 2 4 6	0 1 2 3 4 5 6
seven inches = one foot	0 4 8	0 4	0 4	0 2 4 6	0 2 4 6	0 1 2 3 4 5 6
seven and one half inches = one foot	0 4 8 16	0 4 8	0 4	0 2 4 6	0 2 4 6	0 1 2 3 4 5 6
eight inches = one foot	0 4 8	0 4	0 4	0 2 4 6	0 2 4 6	0 1 2 3 4 5 6
eight and one half inches = one foot	0 4 8 16	0 4 8	0 4	0 2 4 6	0 2 4 6	0 1 2 3 4 5 6
nine inches = one foot	0 4 8	0 4	0 4	0 2 4 6	0 2 4 6	0 1 2 3 4 5 6
nine and one half inches = one foot	0 4 8 16	0 4 8	0 4	0 2 4 6	0 2 4 6	0 1 2 3 4 5 6
ten inches = one foot	0 4 8	0 4	0 4	0 2 4 6	0 2 4 6	0 1 2 3 4 5 6
ten and one half inches = one foot	0 4 8 16	0 4 8	0 4	0 2 4 6	0 2 4 6	0 1 2 3 4 5 6
eleven inches = one foot	0 4 8	0 4	0 4	0 2 4 6	0 2 4 6	0 1 2 3 4 5 6
eleven and one half inches = one foot	0 4 8 16	0 4 8	0 4	0 2 4 6	0 2 4 6	0 1 2 3 4 5 6
twelve inches = one foot	0 4 8	0 4	0 4	0 2 4 6	0 2 4 6	0 1 2 3 4 5 6

 

7/27/2022 11:57:02 AM

VA FORM 08-6231

DOOR SCHEDULE												
MARK	ROOM	FIRE RATING	WIDTH	HEIGHT	PANEL TYPE	GLAZING TYPE	FRAME TYPE	HEAD	JAMB	SILL	HARDWARE GROUP	COMMENTS
1802A	ELECTRICAL	-	4' - 0"	7' - 0"	WD-F	-	HM-001	1/A-600	2/A-600	--	HW-4	
1802B	ELECTRICAL	-	4' - 0"	7' - 0"	WD-F	-	HM-001	1/A-600	2/A-600	--	HW-4	
1802C	ELECTRICAL	45 MIN	4' - 0"	7' - 0"	WD-F	-	HM-001	1/A-600	2/A-600	--	HW-4	
1802D	ELECTRICAL	-	4' - 0"	7' - 0"	WD-F	-	HM-001	1/A-600	2/A-600	--	HW-4	
1803	STAIRS	90 MIN	6' - 0"	7' - 0"	WD-F	-	HM-001	3/A-600	4/A-600	--	HW-5	
1803A	STAIRS	90 MIN	6' - 0"	7' - 0"	HM-F	-	HM-001	9/A-600	10/A-600	11/A-600	HW-1	FOUR SIDED DOOR FRAME, FULL DEPTH OF OPENING, MASONRY HEAD
1803B	STAIRS	90 MIN	6' - 0"	7' - 0"	HM-F	-	HM-001	9/A-600	10/A-600	11/A-600	HW-1	FOUR SIDED DOOR FRAME, FULL DEPTH OF OPENING, MASONRY HEAD
1901	OPEN SPACE	-	4' - 0"	7' - 0"	HM-F	-	HM-001	1/A-600	2/A-600	--	HW-14	
1902	IT	45 MIN/SMOKE	4' - 0"	7' - 0"	HM-F	-	HM-001	1/A-600	2/A-600	--	HW-7	COORDINATE CARD READER; RE: SPEC AND ELECTRICAL
1903A	ANTEROOM, SOILED TRANSITION / DROP-OFF	SMOKE	4' - 0"	7' - 0"	WD-HG	T	HM-001	1/A-600	2/A-600	--	HW-14	
1903B	ANTEROOM, SOILED TRANSITION / DROP-OFF	-	4' - 0"	7' - 0"	WD-HG	T	FRP-001	1/A-600	2/A-600	--	HW-14	
1904A	SCOPE DROP OFF	SMOKE	4' - 0"	7' - 0"	WD-HG	T	HM-001	1/A-600	2/A-600	--	HW-10	COORDINATE AUTO DOOR OPENER; RE: SPEC AND ELECTRICAL
1904B	SCOPE DROP OFF	-	4' - 0"	7' - 0"	WD-HG	T	FRP-001	1/A-600	2/A-600	--	HW-11	COORDINATE AUTO DOOR OPENER; RE: SPEC AND ELECTRICAL
1906A	SCOPE ANTE	SMOKE	4' - 0"	7' - 0"	WD-HG	T	HM-001	1/A-600	2/A-600	--	HW-14	COORDINATE AUTO DOOR OPENER; RE: SPEC AND ELECTRICAL
1906B	SCOPE ANTE	-	4' - 0"	7' - 0"	WD-HG	T	HM-001	1/A-600	2/A-600	--	HW-20	COORDINATE AUTO DOOR OPENER; RE: SPEC AND ELECTRICAL
1907	WOMEN'S LOCKER	-	3' - 6"	7' - 0"	WD-F	-	HM-001	1/A-600	2/A-600	--	HW-12	
1907A	WOMEN'S RR	-	3' - 6"	7' - 0"	WD-F	-	HM-001	1/A-600	2/A-600	--	HW-21	COORDINATE AUTO DOOR OPENER; RE: SPEC AND ELECTRICAL
1907B	WOMEN'S RR	-	3' - 6"	7' - 0"	WD-F	-	HM-001	1/A-600	2/A-600	--	HW-22	
1907C	WOMEN'S SHOWER	-	3' - 6"	7' - 0"	WD-F	-	HM-001	1/A-600	2/A-600	--	HW-21	
1908	MEN'S LOCKER	-	3' - 6"	7' - 0"	WD-F	-	HM-001	1/A-600	2/A-600	--	HW-12	
1908A	MEN'S RR	-	3' - 6"	7' - 0"	WD-F	-	HM-001	1/A-600	2/A-600	--	HW-21	COORDINATE AUTO DOOR OPENER; RE: SPEC AND ELECTRICAL
1908B	MEN'S RR	-	3' - 6"	7' - 0"	WD-F	-	HM-001	1/A-600	2/A-600	--	HW-22	
1908C	MEN'S SHOWER	-	3' - 6"	7' - 0"	WD-F	-	HM-001	1/A-600	2/A-600	--	HW-21	
1909	BREAK ROOM	-	3' - 6"	7' - 0"	WD-HG	T	HM-001	1/A-600	2/A-600	--	HW-18	
1910	OPEN OFFICE/TRAINING	-	3' - 0"	7' - 0"	WD-NV	T	HM-001	1/A-600	2/A-600	--	HW-14	
1911A	ANTE VENDOR DROP OFF	SMOKE	3' - 6"	7' - 0"	WD-HG	T	HM-001	1/A-600	2/A-600	--	HW-14	
1911B	ANTE VENDOR DROP OFF	-	3' - 6"	7' - 0"	FRP-HG	T	FRP-001	1/A-600	2/A-600	--	HW-14	
1912	H2O	-	3' - 6"	7' - 0"	WD-F	-	HM-001	1/A-600	2/A-600	--	HW-8	
1913A	CART PASS	SMOKE	3' - 6"	7' - 0"	WD-HG	T	HM-001	1/A-600	2/A-600	--	HW-10	COORDINATE AUTO DOOR OPENER; RE: SPEC AND ELECTRICAL
1913B	CART PASS	-	4' - 0"	7' - 0"	FRP-HG	T	FRP-001	1/A-600	2/A-600	--	HW-11	COORDINATE AUTO DOOR OPENER; RE: SPEC AND ELECTRICAL
1914	HAC	-	3' - 6"	7' - 0"	FRP-F	-	FRP-001	1/A-600	2/A-600	--	HW-7	
1916A	MANUAL CART WASH	-	4' - 0"	7' - 0"	FRP-F	T	FRP-001	1/A-600	2/A-600	--	HW-13	
1916B	MANUAL CART WASH	-	4' - 0"	7' - 0"	FRP-F	T	FRP-001	1/A-600	2/A-600	--	HW-13	
1919	CART DRY	-	4' - 0"	7' - 0"	FRP-HG	T	FRP-001	1/A-600	2/A-600	--	HW-13	COORDINATE AUTO DOOR OPENER; RE: SPEC AND ELECTRICAL
1920	STERILIZATION	-	2' - 6"	7' - 0"	FRP-F	-	FRP-001	1/A-600	2/A-600	--	HW-19	
1921	STERILE STG	SMOKE	6' - 0"	7' - 0"	WD-NV	T	HM-001	1/A-600	2/A-600	--	HW-9	COORDINATE AUTO DOOR OPENER; RE: SPEC AND ELECTRICAL
1923	PREP ASSEMBLY	-	3' - 6"	7' - 0"	FRP-HG	T	FRP-001	1/A-600	2/A-600	--	HW-11	COORDINATE AUTO DOOR OPENER; RE: SPEC AND ELECTRICAL
1924A	ANTE	SMOKE	4' - 0"	7' - 0"	WD-HG	T	HM-001	1/A-600	2/A-600	--	HW-10	COORDINATE AUTO DOOR OPENER; RE: SPEC AND ELECTRICAL
1924B	ANTE	-	4' - 0"	7' - 0"	FRP-HG	T	FRP-001	1/A-600	2/A-600	--	HW-11	COORDINATE AUTO DOOR OPENER; RE: SPEC AND ELECTRICAL
1925	HAC	-	3' - 6"	7' - 0"	FRP-F	-	FRP-001	1/A-600	2/A-600	--	HW-7	
1926	CONFERENCE	-	3' - 0"	7' - 0"	WD-NV	T	HM-001	1/A-600	2/A-600	--	HW-15	
1927	OPEN OFFICE	-	3' - 0"	7' - 0"	WD-F	-	HM-001	1/A-600	2/A-600	--	HW-15	
1928	OFFICE	-	3' - 0"	7' - 0"	WD-F	-	HM-001	1/A-600	2/A-600	--	HW-16	
1929	OFFICE	-	3' - 0"	7' - 0"	WD-F	-	HM-001	1/A-600	2/A-600	--	HW-16	
1930	COPIER ROOM	-	3' - 0"	7' - 0"	WD-F	-	HM-001	1/A-600	2/A-600	--	HW-17	
1931	STAIRS	90 MIN	4' - 0"	7' - 0"	WD-F	-	HM-001	1/A-600	2/A-600	--	HW-3	COORDINATE CARD READER; RE: SPEC AND ELECTRICAL
C4	CORRIDOR	-	6' - 0"	7' - 0"	HM-F	-	HM-001	5/A-600	6/A-600	7/A-600	HW-1	FOUR SIDED DOOR FRAME, FULL DEPTH OF OPENING, MASONRY HEAD
C50	CORRIDOR	-	6' - 0"	7' - 0"	WD-NV	T	HM-001	1/A-600	2/A-600	--	HW-2	COORDINATE CARD READER; RE: SPEC AND ELECTRICAL
H25N	CORRIDOR	90 MIN	6' - 0"	7' - 0"	WD-F	-	HM-001	5/A-600	6/A-600	--	HW-6	


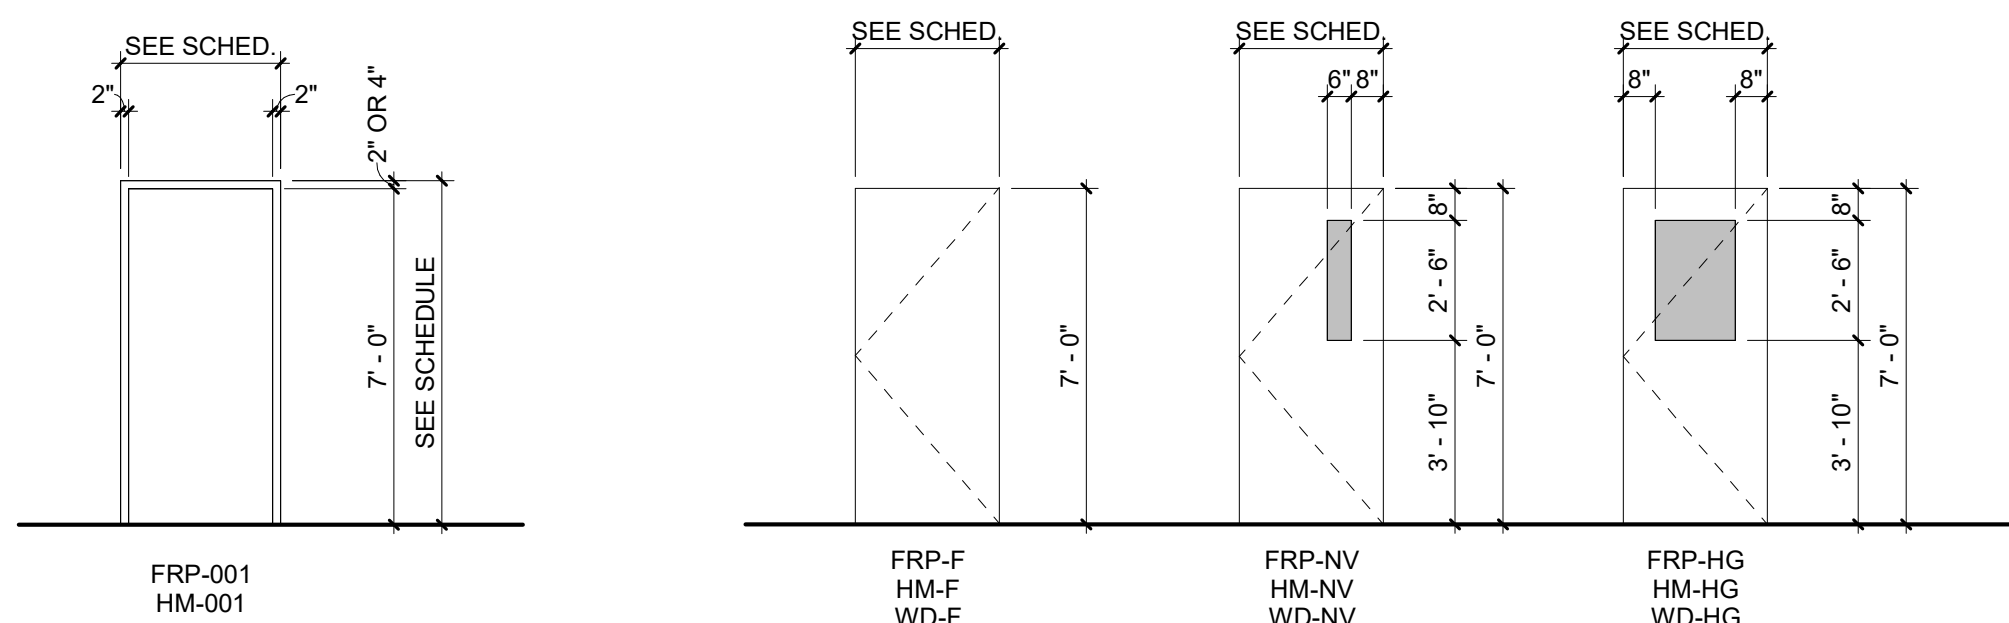


DOOR LEGEND:


FRP	FIBERGLASS
FRP-F	FIBERGLASS - FLUSH FULL
FRP-HG	FIBERGLASS - HALF GLASS
FRP-NV	FIBERGLASS - NARROW VISION
HM	HOLLOW METAL
HM-F	HOLLOW METAL - FLUSH FULL
HM-HG	HOLLOW METAL - HALF GLASS
HM-NV	HOLLOW METAL - NARROW VISION
S	SMOKE PASSAGE RATED
WD-F	WOOD - FLUSH FULL
WD-HG	WOOD - HALF GLASS
WD-NV	WOOD - NARROW VISION

GLAZING LEGEND:


T	TEMPERED GLASS
---	----------------

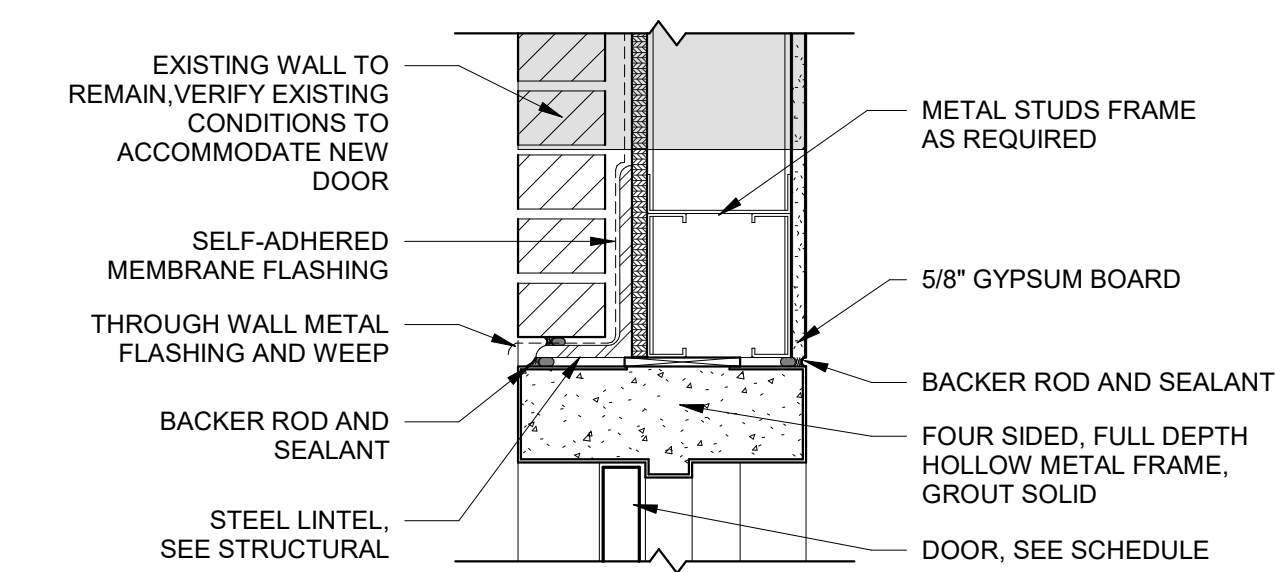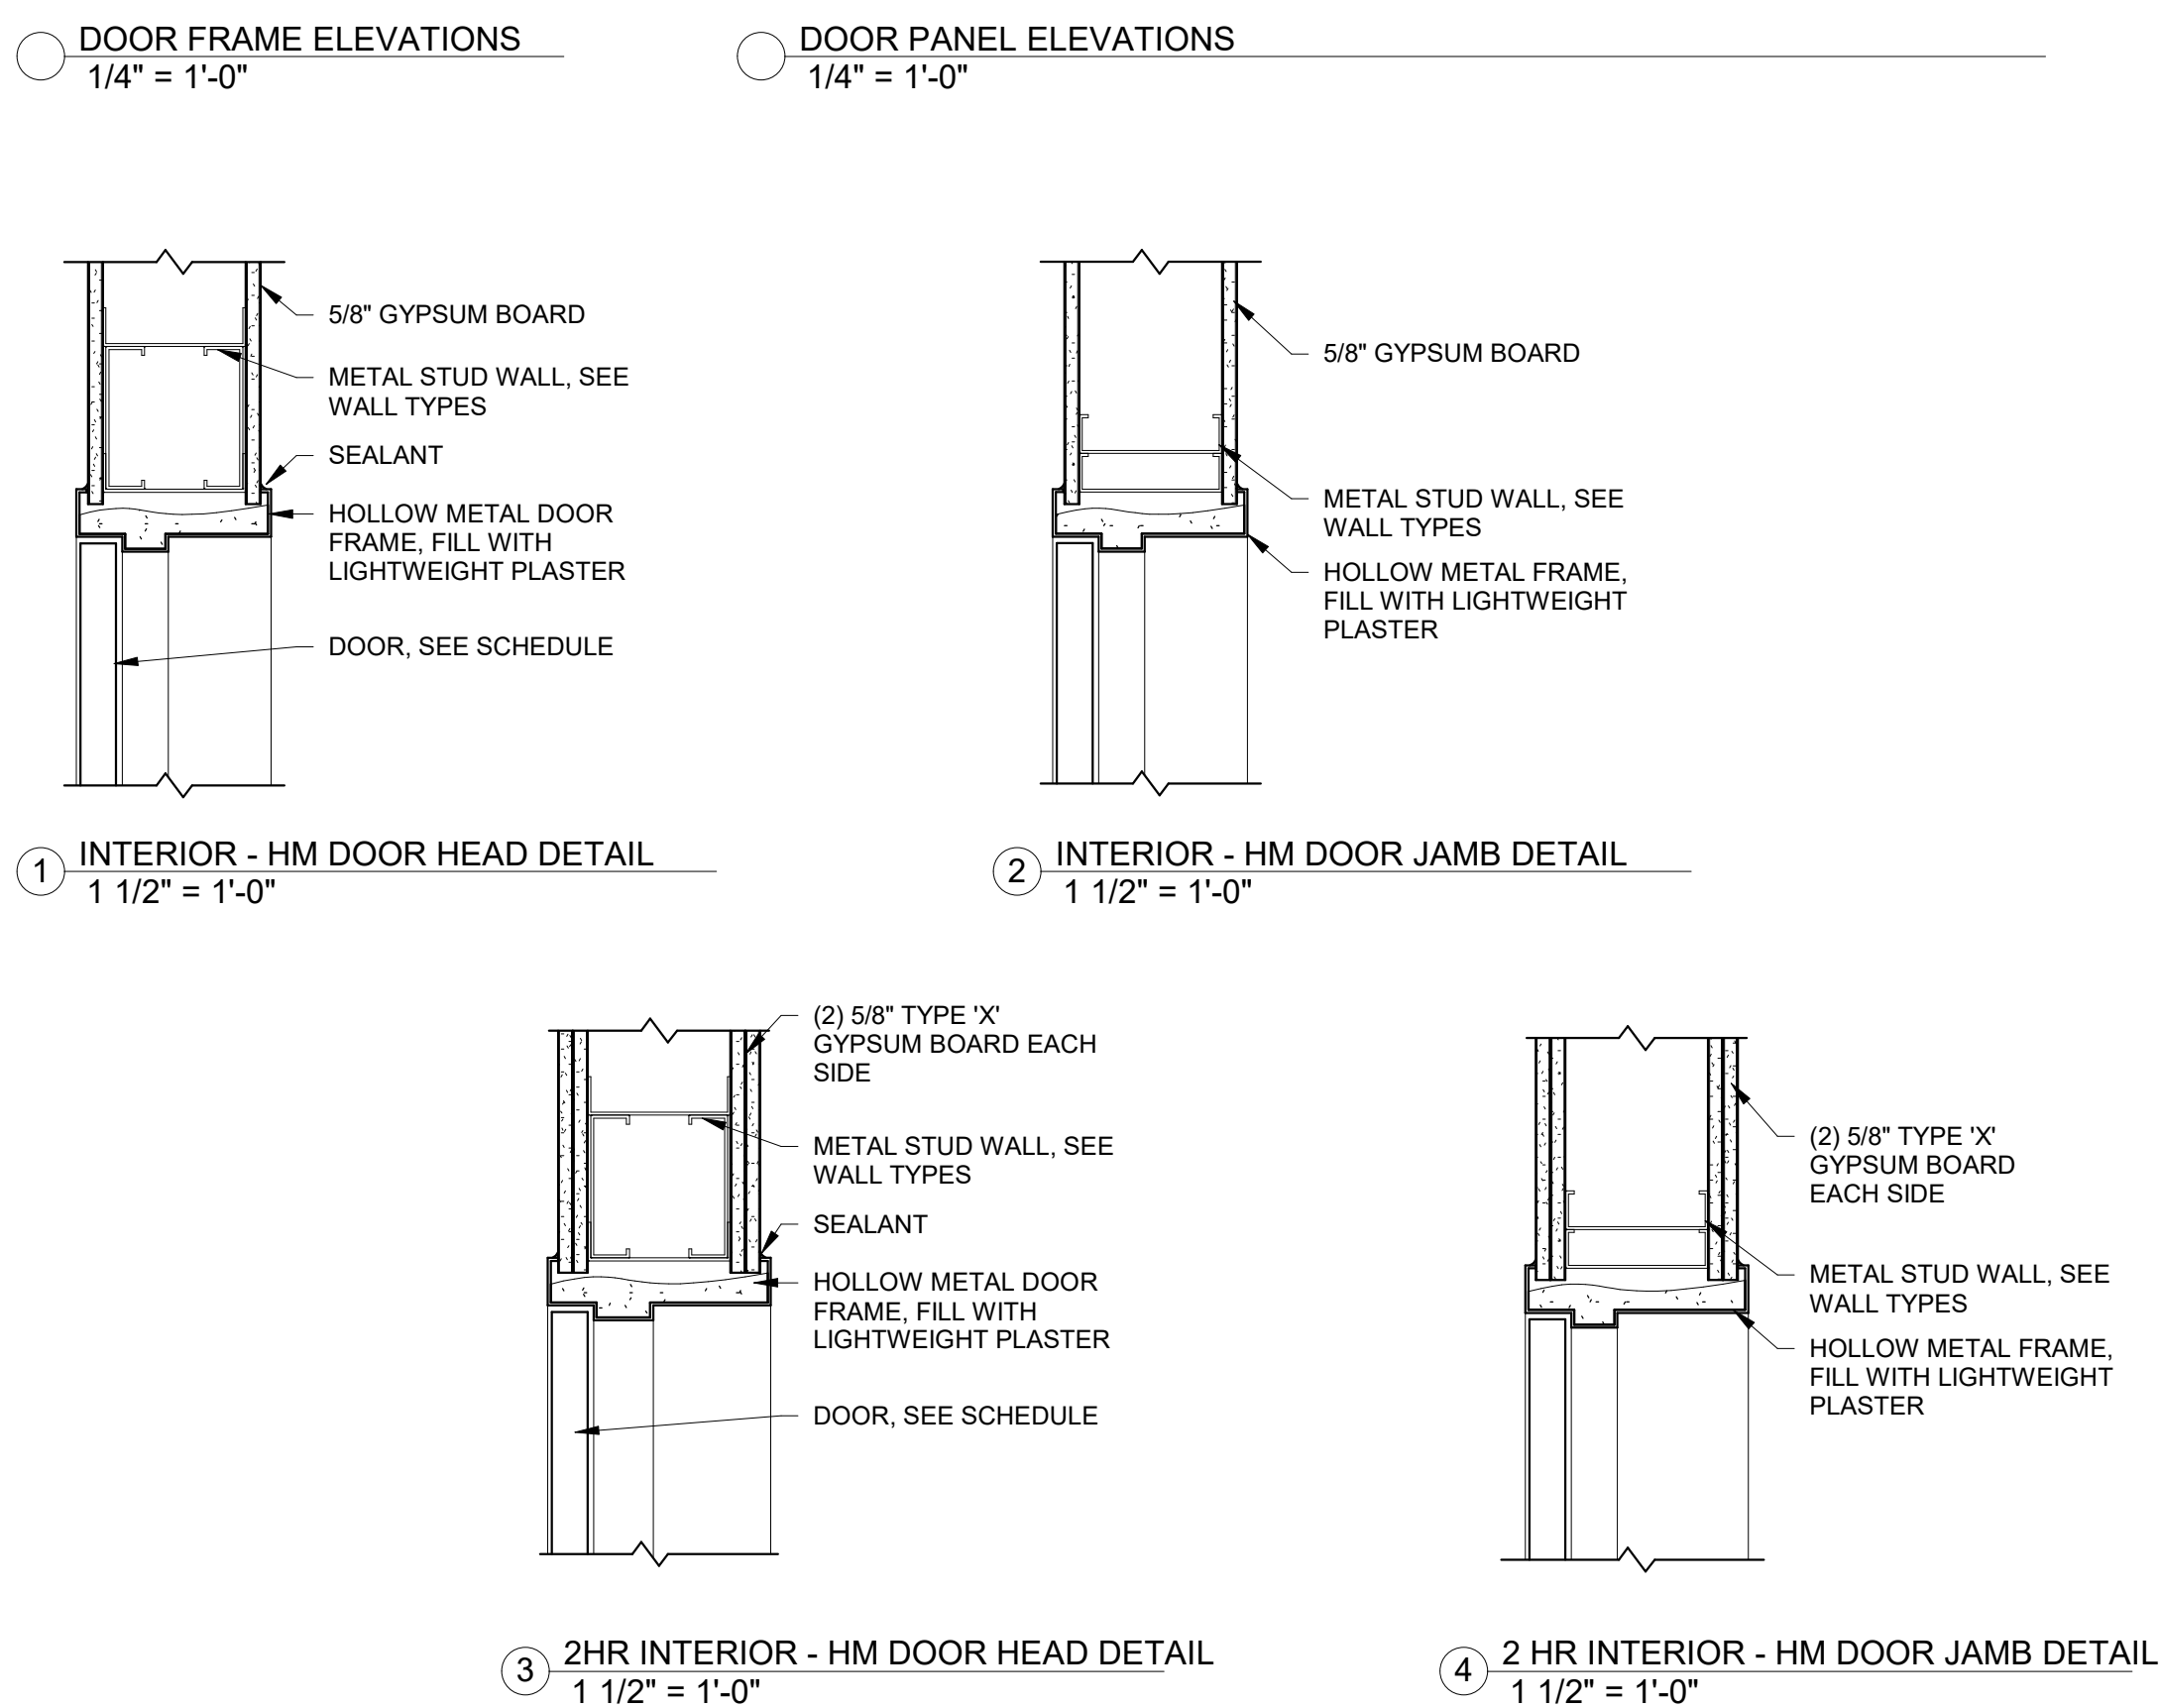

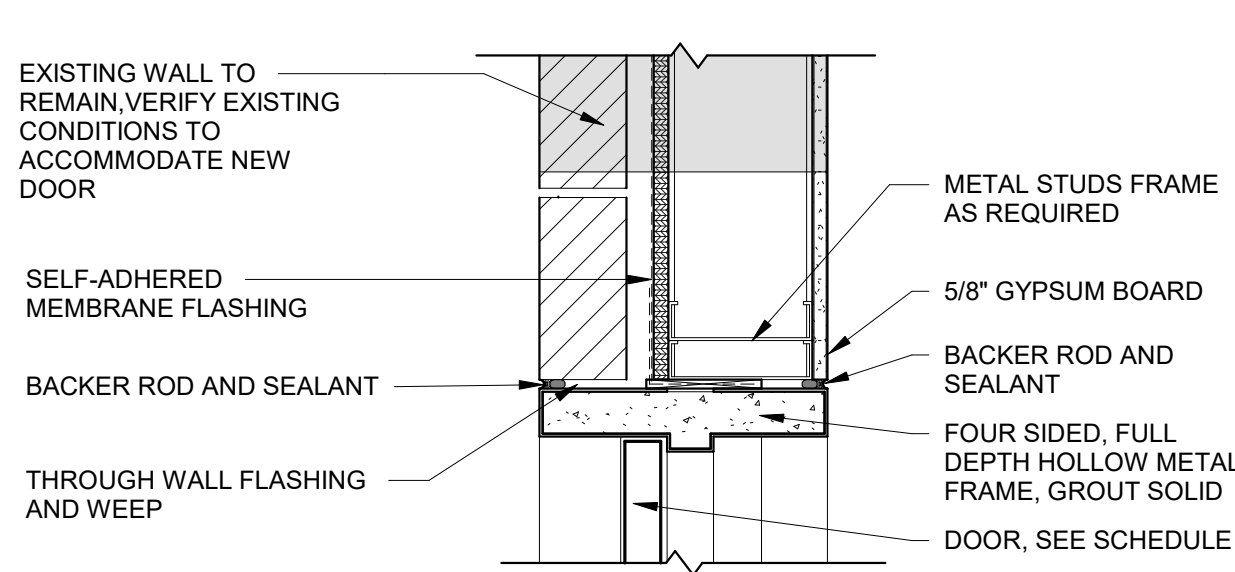
5 EXTERIOR - HM DOOR HEAD DETAIL
1 1/2" = 1'-0"



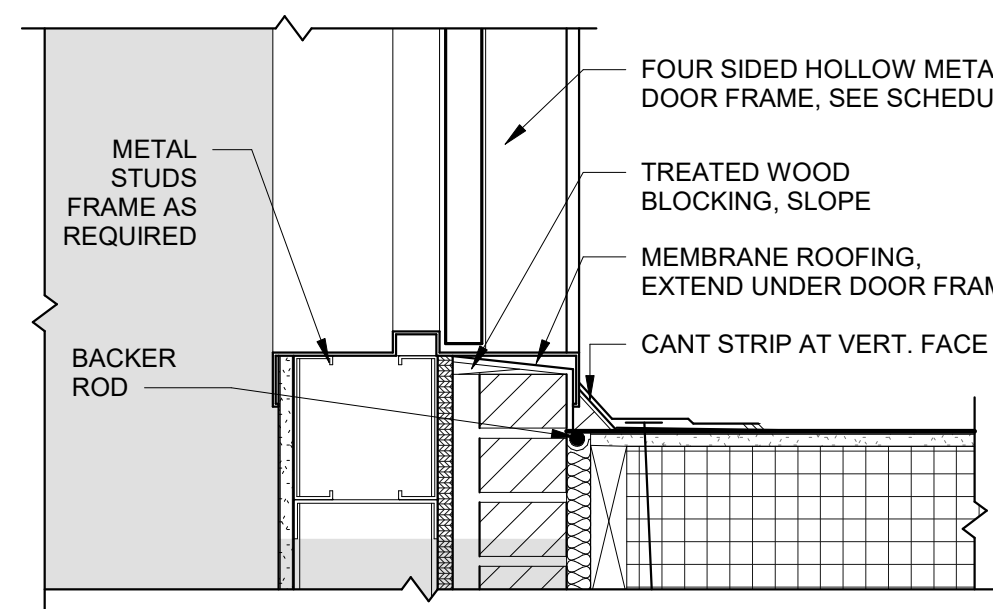
6 EXTERIOR - HM DOOR JAMB DETAIL
1 1/2" = 1'-0"



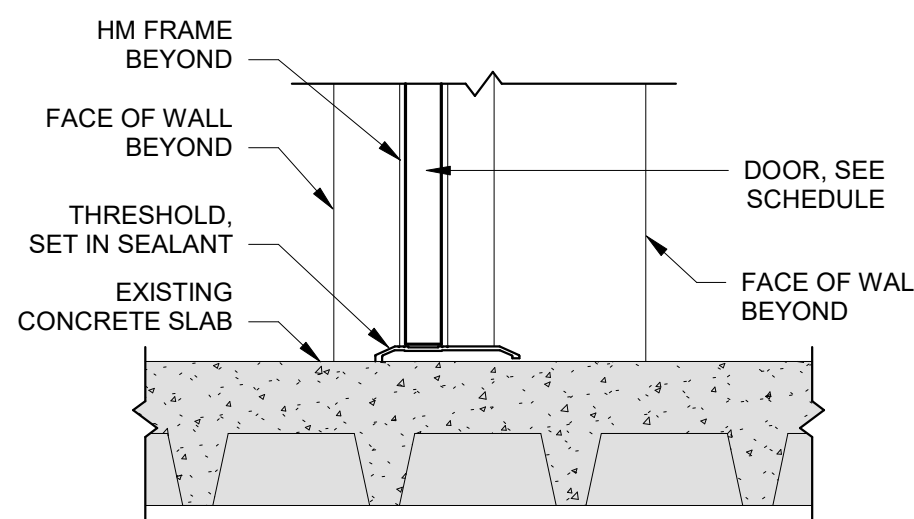
7 EXTERIOR - HM DOOR SILL DETAIL @ EXTERIOR WALL
1 1/2" = 1'-0"



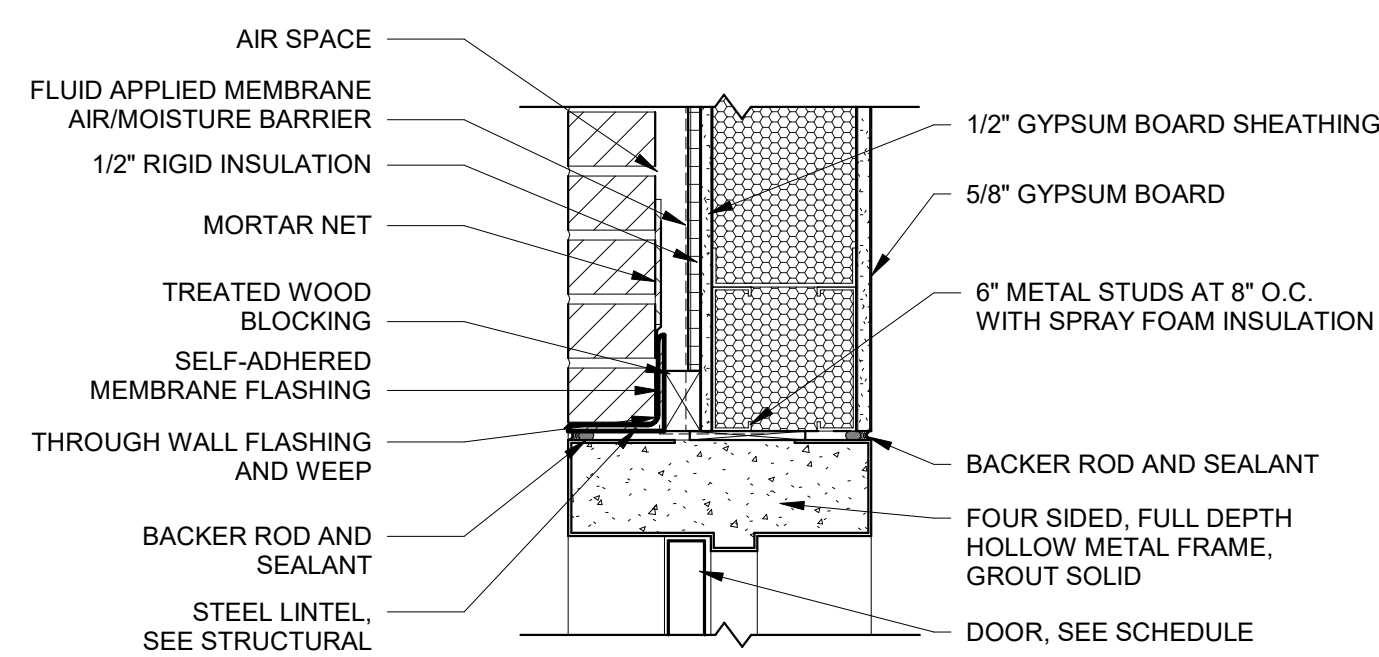
8 HM DOOR SILL DETAIL INTERSTITIAL
1 1/2" = 1'-0"



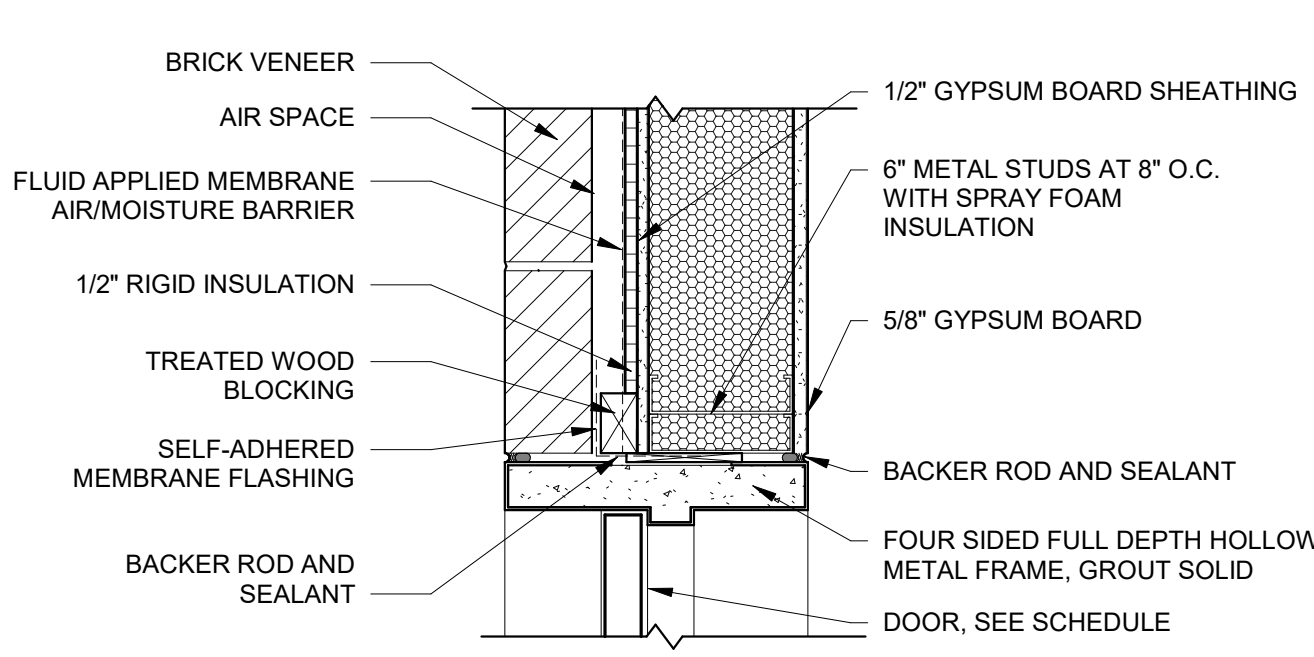9 EXTERIOR - HM DOOR HEAD DETAIL
1 1/2" = 1'-0"



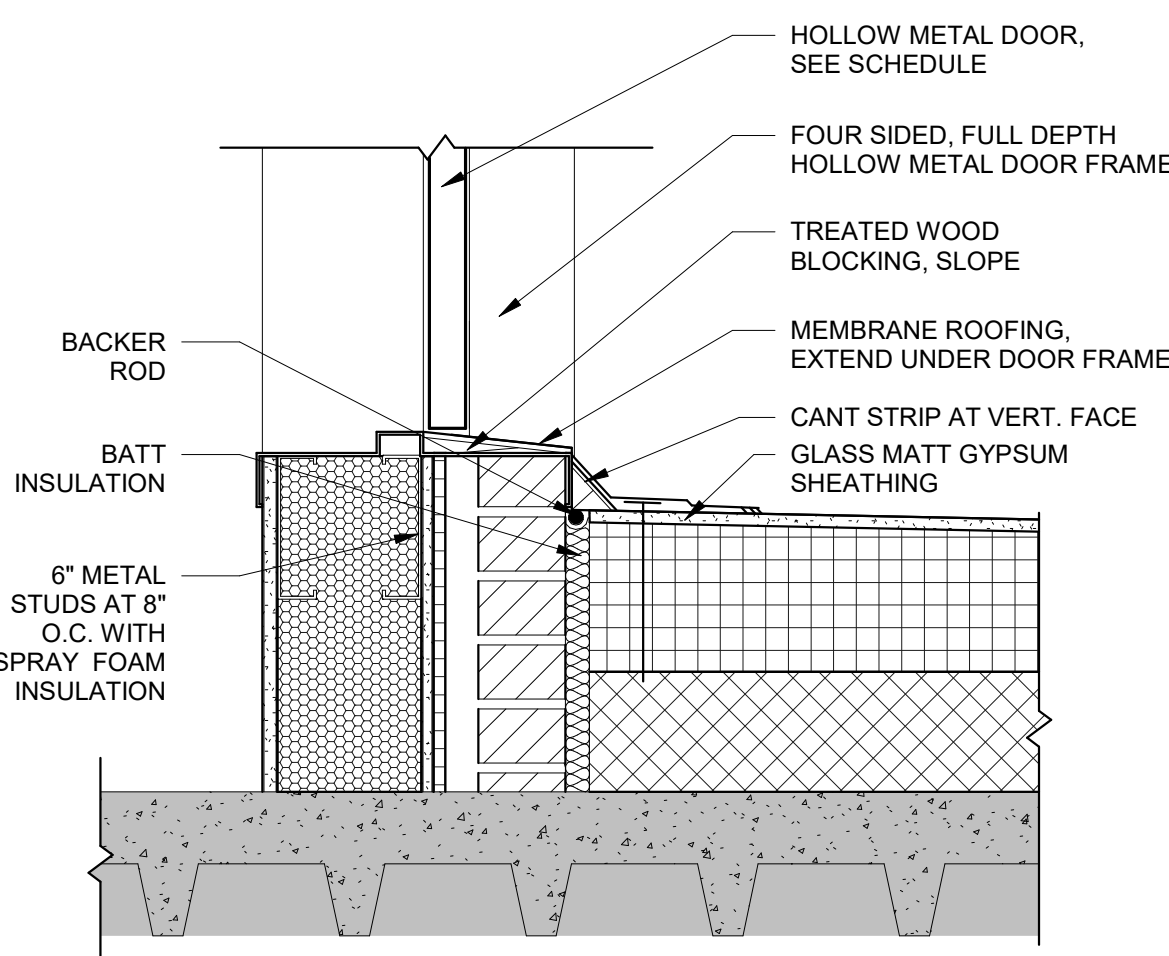10 EXTERIOR - HM DOOR JAMB DETAIL
1 1/2" = 1'-0"




11 EXTERIOR - HM DOOR SILL DETAIL
1 1/2" = 1'-0"

CONSTRUCTION DOCUMENTS


COMPLIANCY REVIEW INCLUDED Revisions:		2/23/2024 Date	
CONSULTANTS:			
 TERRASITE DESIGN 1635 DEADWOOD AVENUE RAPID CITY, SOUTH DAKOTA 57702 PH: (605) 791-1736		 ALBERTSON ENGINEERING, INC. 315 NORTH MAIN AVENUE, SUITE 200 SIOUX FALLS, SOUTH DAKOTA 57104 PH: (605) 274-0880	
 FARRIS ENGINEERING 12700 WEST DODGE ROAD OMAHA, NEBRASKA 68154 PH: (402) 330-5900			
ARCHITECT		ARCHITECT	
 FOURFRONT DESIGN, INC. 517 7TH STREET RAPID CITY, SOUTH DAKOTA 57701 PH: (605) 342-9470 FAX: (605) 242-2377 WWW.FOURFRONTDESIGN.COM		 FOURFRONT DESIGN, INC. 517 7TH STREET RAPID CITY, SOUTH DAKOTA 57701 PH: (605) 342-9470 FAX: (605) 242-2377 WWW.FOURFRONTDESIGN.COM	
Drawing Title DOOR SCHEDULE, ELEVATIONS AND DETAILS		Project Title Design/Construct Sterile Processing Service- Omaha VA Medical Center	
Approved: Project Director Omaha VA Medical Center		Location 4101 Woolworth Ave #4199 Omaha, Ne 68105	
Date 11/23/2020		Checked JL	
Drawn JGC		Project Number 16.2330.A08	
		Building Number 25	
		Drawing Number A-600	
		Dwg. 77 of 193	
		Office of Construction and Facilities Management Department of Veterans Affairs	

DOOR SCHEDULE												
MARK	ROOM	FIRE RATING	WIDTH	HEIGHT	PANEL TYPE	GLAZING TYPE	FRAME TYPE	HEAD	JAMB	SILL	HARDWARE GROUP	COMMENTS
1802A	ELECTRICAL	-	4' - 0"	7' - 0"	WD-F	-	HM-001	1/A-600	2/A-600	--	HW-4	FOUR SIDED DOOR FRAME, FULL DEPTH OF OPENING, MASONRY HEAD
1802B	ELECTRICAL	-	4' - 0"	7' - 0"	WD-F	-	HM-001	1/A-600	2/A-600	--	HW-4	
1802C	ELECTRICAL	45 MIN	4' - 0"	7' - 0"	WD-F	-	HM-001	1/A-600	2/A-600	--	HW-4	
1802D	ELECTRICAL	-	4' - 0"	7' - 0"	WD-F	-	HM-001	1/A-600	2/A-600	--	HW-4	
1803	STAIRS	90 MIN	6' - 0"	7' - 0"	WD-F	-	HM-001	3/A-600	4/A-600	--	HW-5	FOUR SIDED DOOR FRAME, FULL DEPTH OF OPENING, MASONRY HEAD
1803A	STAIRS	90 MIN	6' - 0"	7' - 0"	HM-F	-	HM-001	9/A-600	10/A-600	11/A-600	HW-1	
1803B	STAIRS	90 MIN	6' - 0"	7' - 0"	HM-F	-	HM-001	9/A-600	10/A-600	11/A-600	HW-1	FOUR SIDED DOOR FRAME, FULL DEPTH OF OPENING, MASONRY HEAD
1901	OPEN SPACE	-	4' - 0"	7' - 0"	HM-F	-	HM-001	1/A-600	2/A-600	--	HW-14	
1902	IT	45 MIN/SMOKE	4' - 0"	7' - 0"	HM-F	-	HM-001	1/A-600	2/A-600	--	HW-7	COORDINATE CARD READER; RE: SPEC AND ELECTRICAL
1903A	ANTEROOM, SOILED TRANSITION / DROP-OFF	SMOKE	4' - 0"	7' - 0"	WD-HG	T	HM-001	1/A-600	2/A-600	--	HW-14	
1903B	ANTEROOM, SOILED TRANSITION / DROP-OFF	-	4' - 0"	7' - 0"	WD-HG	T	FRP-001	1/A-600	2/A-600	--	HW-14	COORDINATE AUTO DOOR OPENER; RE: SPEC AND ELECTRICAL
1904A	SCOPE DROP OFF	SMOKE	4' - 0"	7' - 0"	WD-HG	T	HM-001	1/A-600	2/A-600	--	HW-10	
1904B	SCOPE DROP OFF	-	4' - 0"	7' - 0"	WD-HG	T	FRP-001	1/A-600	2/A-600	--	HW-11	
1906A	SCOPE ANTE	SMOKE	4' - 0"	7' - 0"	WD-HG	T	HM-001	1/A-600	2/A-600	--	HW-14	
1906B	SCOPE ANTE	-	4' - 0"	7' - 0"	WD-HG	T	HM-001	1/A-600	2/A-600	--	HW-20	COORDINATE AUTO DOOR OPENER; RE: SPEC AND ELECTRICAL
1907	WOMEN'S LOCKER	-	3' - 6"	7' - 0"	WD-F	-	HM-001	1/A-600	2/A-600	--	HW-12	
1907A	WOMEN'S RR	-	3' - 6"	7' - 0"	WD-F	-	HM-001	1/A-600	2/A-600	--	HW-21	COORDINATE AUTO DOOR OPENER; RE: SPEC AND ELECTRICAL
1907B	WOMEN'S RR	-	3' - 6"	7' - 0"	WD-F	-	HM-001	1/A-600	2/A-600	--	HW-22	
1907C	WOMEN'S SHOWER	-	3' - 6"	7' - 0"	WD-F	-	HM-001	1/A-600	2/A-600	--	HW-21	COORDINATE AUTO DOOR OPENER; RE: SPEC AND ELECTRICAL
1908	MEN'S LOCKER	-	3' - 6"	7' - 0"	WD-F	-	HM-001	1/A-600	2/A-600	--	HW-12	
1908A	MEN'S RR	-	3' - 6"	7' - 0"	WD-F	-	HM-001	1/A-600	2/A-600	--	HW-21	
1908B	MEN'S RR	-	3' - 6"	7' - 0"	WD-F	-	HM-001	1/A-600	2/A-600	--	HW-22	
1908C	MEN'S SHOWER	-	3' - 6"	7' - 0"	WD-F	-	HM-001	1/A-600	2/A-600	--	HW-21	COORDINATE AUTO DOOR OPENER; RE: SPEC AND ELECTRICAL
1909	BREAK ROOM	-	3' - 6"	7' - 0"	WD-HG	T	HM-001	1/A-600	2/A-600	--	HW-18	
1910	OPEN OFFICE/TRAINING	-	3' - 0"	7' - 0"	WD-NV	T	HM-001	1/A-600	2/A-600	--	HW-14	
1911A	ANTE VENDOR DROP OFF	SMOKE	3' - 6"	7' - 0"	WD-HG	T	HM-001	1/A-600	2/A-600	--	HW-14	
1911B	ANTE VENDOR DROP OFF	-	3' - 6"	7' - 0"	FRP-HG	T	FRP-001	1/A-600	2/A-600	--	HW-14	COORDINATE AUTO DOOR OPENER; RE: SPEC AND ELECTRICAL
1912	H2O	-	3' - 6"	7' - 0"	WD-F	-	HM-001	1/A-600	2/A-600	--	HW-8	
1913A	CART PASS	SMOKE	3' - 6"	7' - 0"	WD-HG	T	HM-001	1/A-600	2/A-600	--	HW-10	
1913B	CART PASS	-	4' - 0"	7' - 0"	FRP-HG	T	FRP-001	1/A-600	2/A-600	--	HW-11	
1914	HAC	-	3' - 6"	7' - 0"	FRP-F	-	FRP-001	1/A-600	2/A-600	--	HW-7	COORDINATE AUTO DOOR OPENER; RE: SPEC AND ELECTRICAL
1916A	MANUAL CART WASH	-	4' - 0"	7' - 0"	FRP-F	T	FRP-001	1/A-600	2/A-600	--	HW-13	
1916B	MANUAL CART WASH	-	4' - 0"	7' - 0"	FRP-F	T	FRP-001	1/A-600	2/A-600	--	HW-13	
1919	CART DRY	-	4' - 0"	7' - 0"	FRP-HG	T	FRP-001	1/A-600	2/A-600	--	HW-13	
1920	STERILIZATION	-	2' - 6"	7' - 0"	FRP-F	-	FRP-001	1/A-600	2/A-600	--	HW-19	COORDINATE AUTO DOOR OPENER; RE: SPEC AND ELECTRICAL
1921	STERILE STG	SMOKE	6' - 0"	7' - 0"	WD-NV	T	HM-001	1/A-600	2/A-600	--	HW-9	
1923	PREP ASSEMBLY	-	3' - 6"	7' - 0"	FRP-HG	T	FRP-001	1/A-600	2/A-600	--	HW-11	
1924A	ANTE	SMOKE	4' - 0"	7' - 0"	WD-HG	T	HM-001	1/A-600	2/A-600	--	HW-10	
1924B	ANTE	-	4' - 0"	7' - 0"	FRP-HG	T	FRP-001	1/A-600	2/A-600	--	HW-11	COORDINATE AUTO DOOR OPENER; RE: SPEC AND ELECTRICAL
1925	HAC	-	3' - 6"	7' - 0"	FRP-F	-	FRP-001	1/A-600	2/A-600	--	HW-7	
1926	SHELL SPACE	-	3' - 0"	7' - 0"	WD-F	-	HM-001	1/A-600	2/A-600	--	HW-15	
1926A	SHELL SPACE	-	3' - 0"	7' - 0"	WD-F	-	HM-001	1/A-600	2/A-600	--	HW-17	
1931	STAIRS	90 MIN	4' - 0"	7' - 0"	WD-F	-	HM-001	1/A-600	2/A-600	--	HW-3	COORDINATE CARD READER; RE: SPEC AND ELECTRICAL
C4	CORRIDOR	-	6' - 0"	7' - 0"	HM-F	-	HM-001	5/A-600	6/A-600	7/A-600	HW-1	
C50	CORRIDOR	-	6' - 0"	7' - 0"	WD-NV	T	HM-001	1/A-600	2/A-600	--	HW-2	FOUR SIDED DOOR FRAME, FULL DEPTH OF OPENING, MASONRY HEAD
H25N	CORRIDOR	90 MIN	6' - 0"	7' - 0"	WD-F	-	HM-001	5/A-600	6/A-600	--	HW-6	

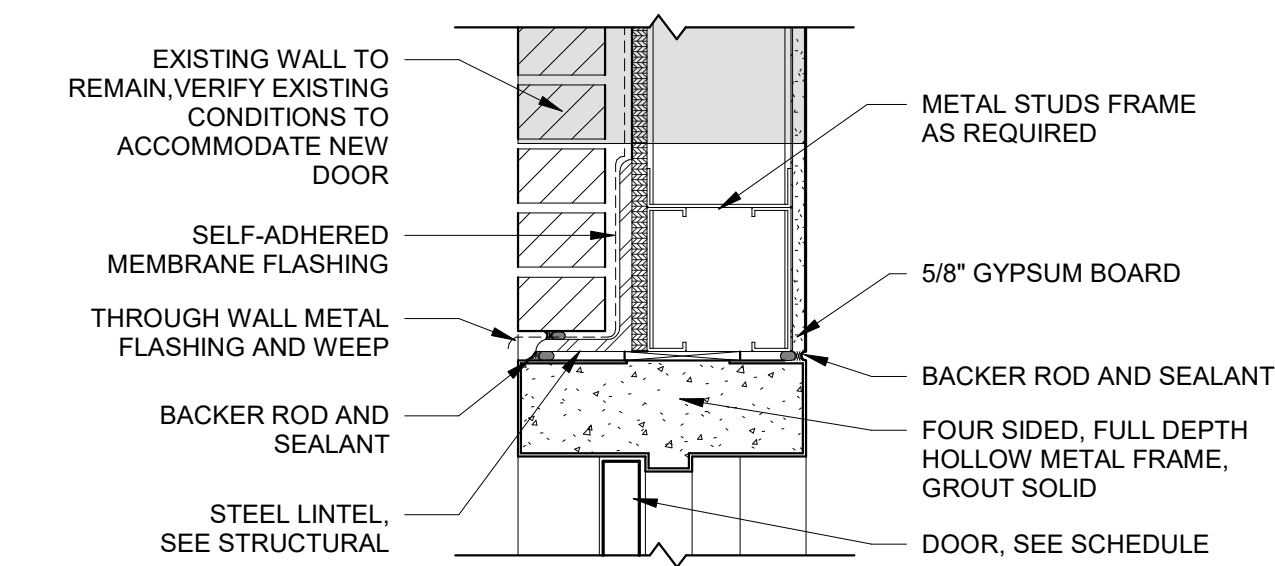
ALTERNATE BID #4



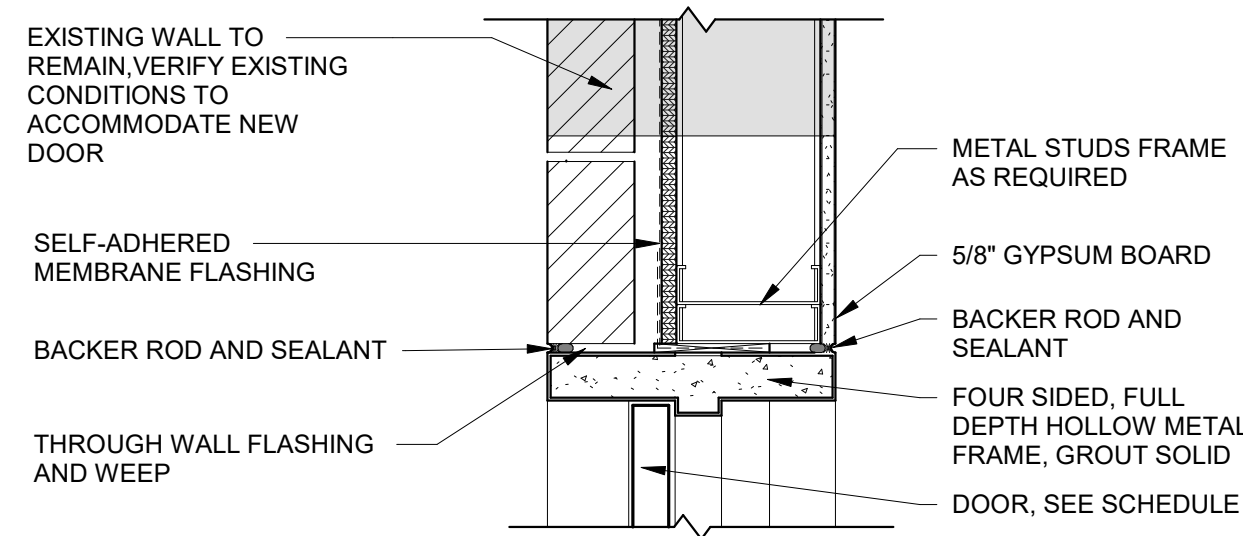
5 EXTERIOR - HM DOOR HEAD DETAIL
1 1/2" = 1'-0"



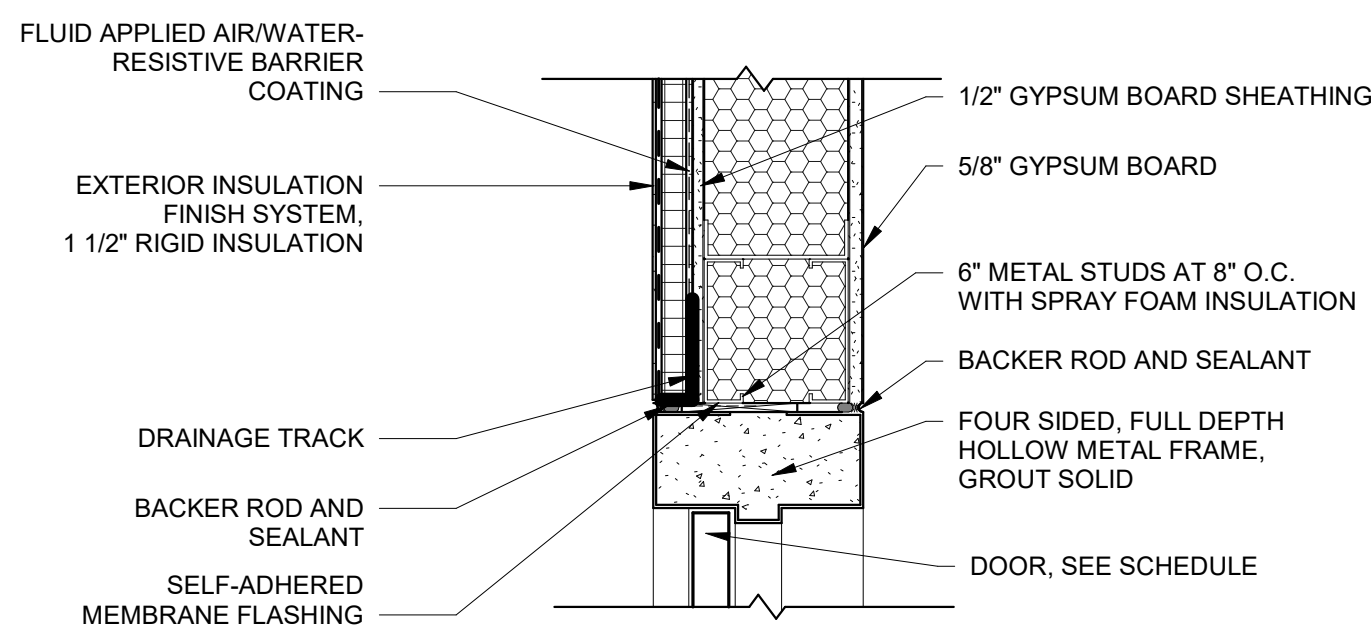
6 EXTERIOR - HM DOOR JAMB DETAIL
1 1/2" = 1'-0"



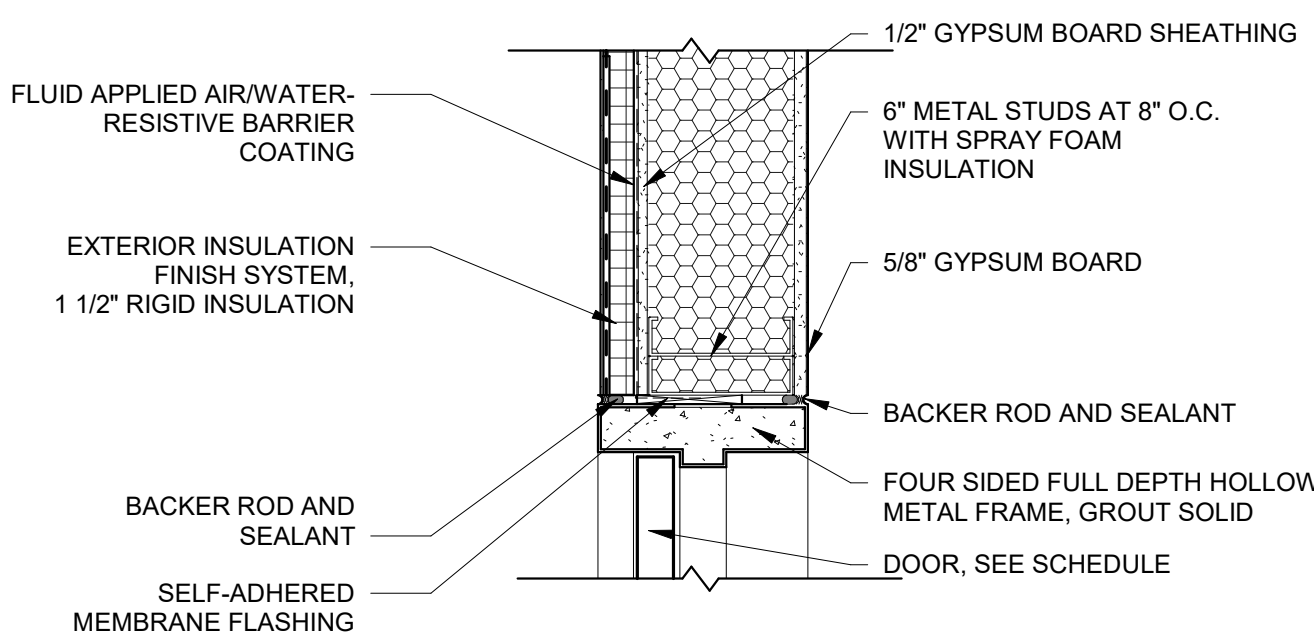
9 EXTERIOR - HM DOOR HEAD DETAIL
1 1/2" = 1'-0"



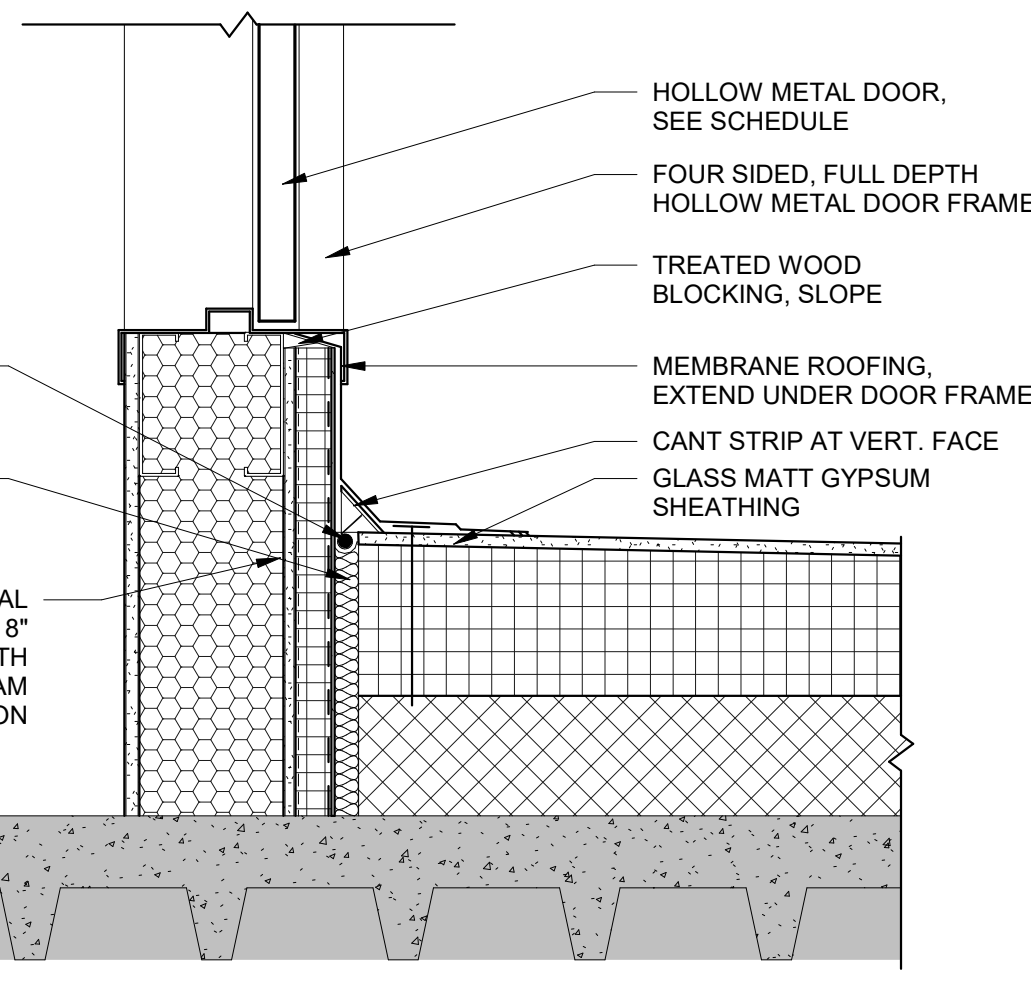
10 EXTERIOR - HM DOOR JAMB DETAIL
1 1/2" = 1'-0"



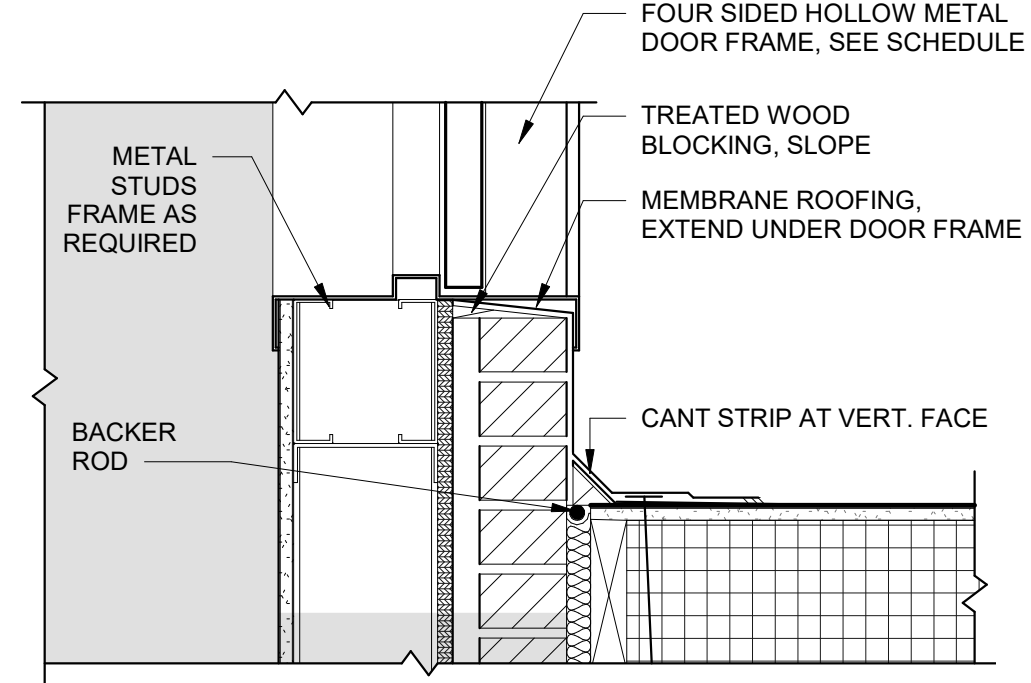
11 EXTERIOR - HM DOOR SILL DETAIL
1 1/2" = 1'-0"



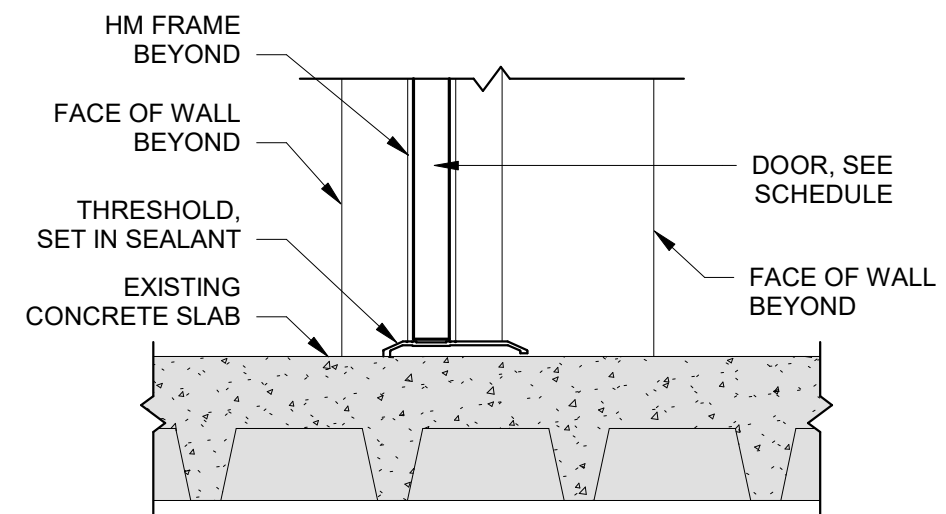
7 EXTERIOR - HM DOOR SILL DETAIL @ EXTERIOR WALL
1 1/2" = 1'-0"



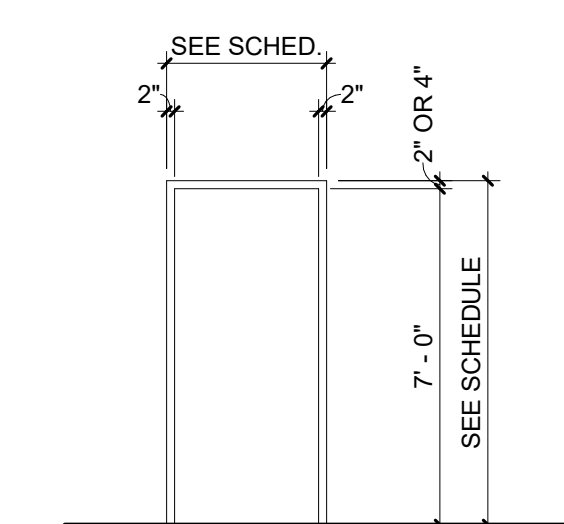
8 HM DOOR SILL DETAIL INTERSTITIAL
1 1/2" = 1'-0"




DOOR FRAME ELEVATIONS
1/4" = 1'-0"

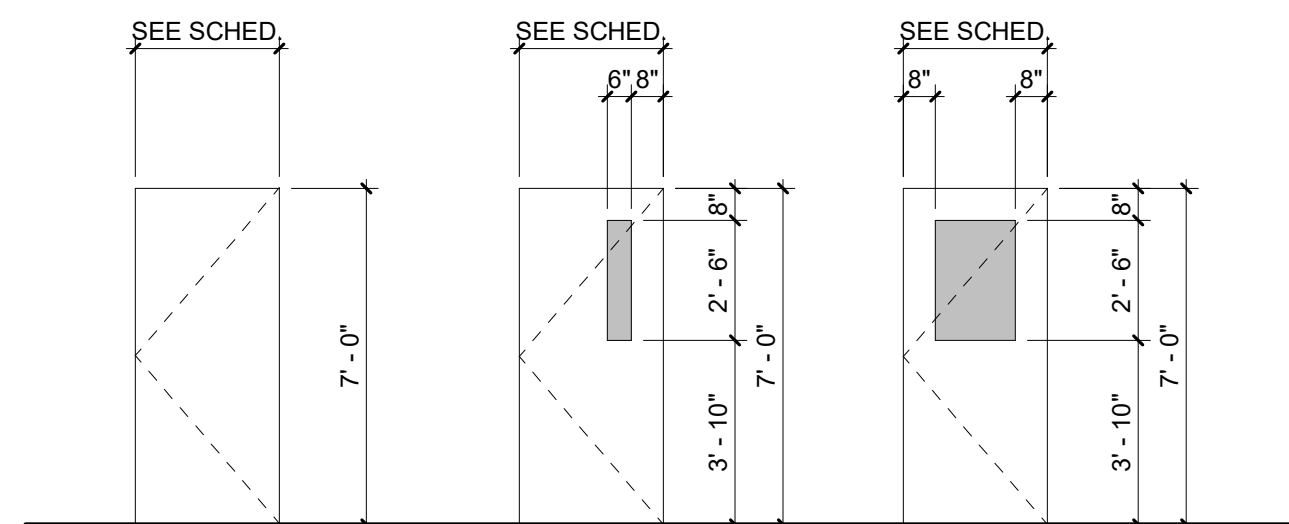


DOOR PANEL ELEVATIONS
1/4" = 1'-0"

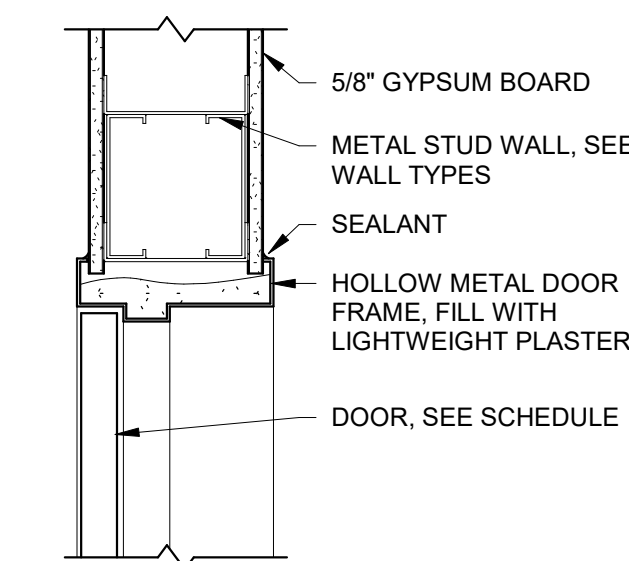

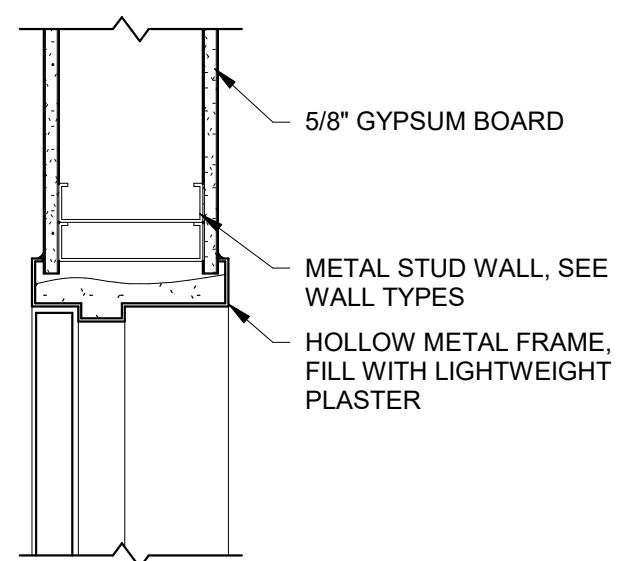
3 INTERIOR - HM DOOR HEAD DETAIL
1 1/2" = 1'-0"



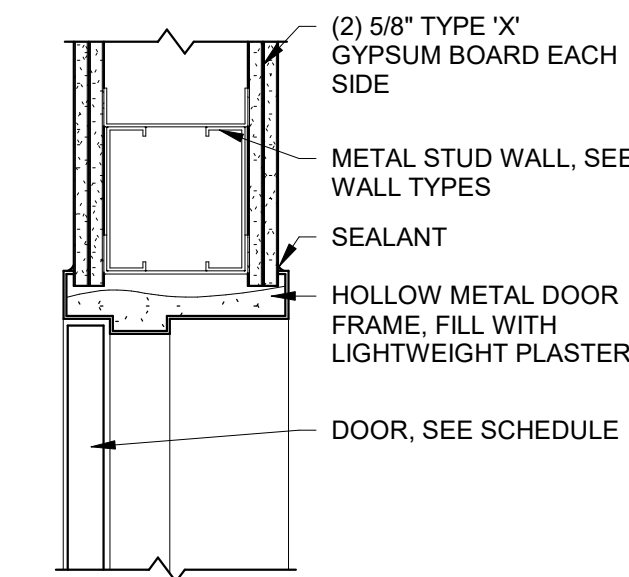2 INTERIOR - HM DOOR JAMB DETAIL
1 1/2" = 1'-0"



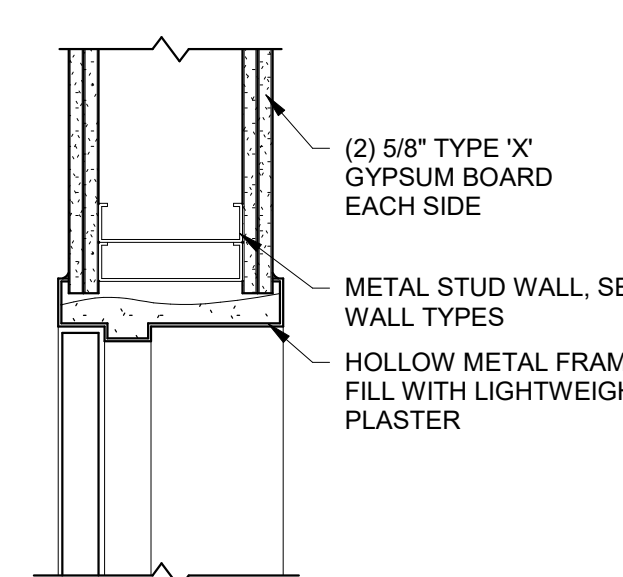3 2HR INTERIOR - HM DOOR HEAD DETAIL
1 1/2" = 1'-0"



4 2 HR INTERIOR - HM DOOR JAMB DETAIL
1 1/2" = 1'-0"

DOOR LEGEND:

FRP	FIBERGLASS
FRP-F	FIBERGLASS - FLUSH FULL
FRP-HG	FIBERGLASS - HALF GLASS
FRP-NV	FIBERGLASS - NARROW VISION
HM	HOLLOW METAL
HM-F	HOLLOW METAL - FLUSH FULL
HM-HG	HOLLOW METAL - HALF GLASS
HM-NV	HOLLOW METAL - NARROW VISION
SMOKE	SMOKE PASSAGE RATED
WD-F	WOOD - FLUSH FULL
WD-HG	WOOD - HALF GLASS
WD-NV	WOOD - NARROW VISION










GLAZING LEGEND:

T	TEMPERED GLASS
---	----------------

COMPLIANCY REVIEW INCLUDED Revisions:		2/23/2024 Date	CONSULTANTS:		ARCHITECT		Drawing Title		Project Title		Project Number		Office of Construction and Facilities Management	
							DOOR SCHEDULE, ELEVATIONS AND DETAILS - ALTERNATIVE BID #4		Design/Construct Sterile Processing Service- Omaha VA Medical Center		16.2330.A08			
							Approved: Project Director Omaha VA Medical Center		Location 4101 Woolworth Ave #4199 Omaha, Ne 68105		Building Number 25		Department of Veterans Affairs	
									Date 11/23/2020		Checked JL		Dwg. 78 of 193	
									Drawn JGC		A-600.1			

GENERAL NOTES:

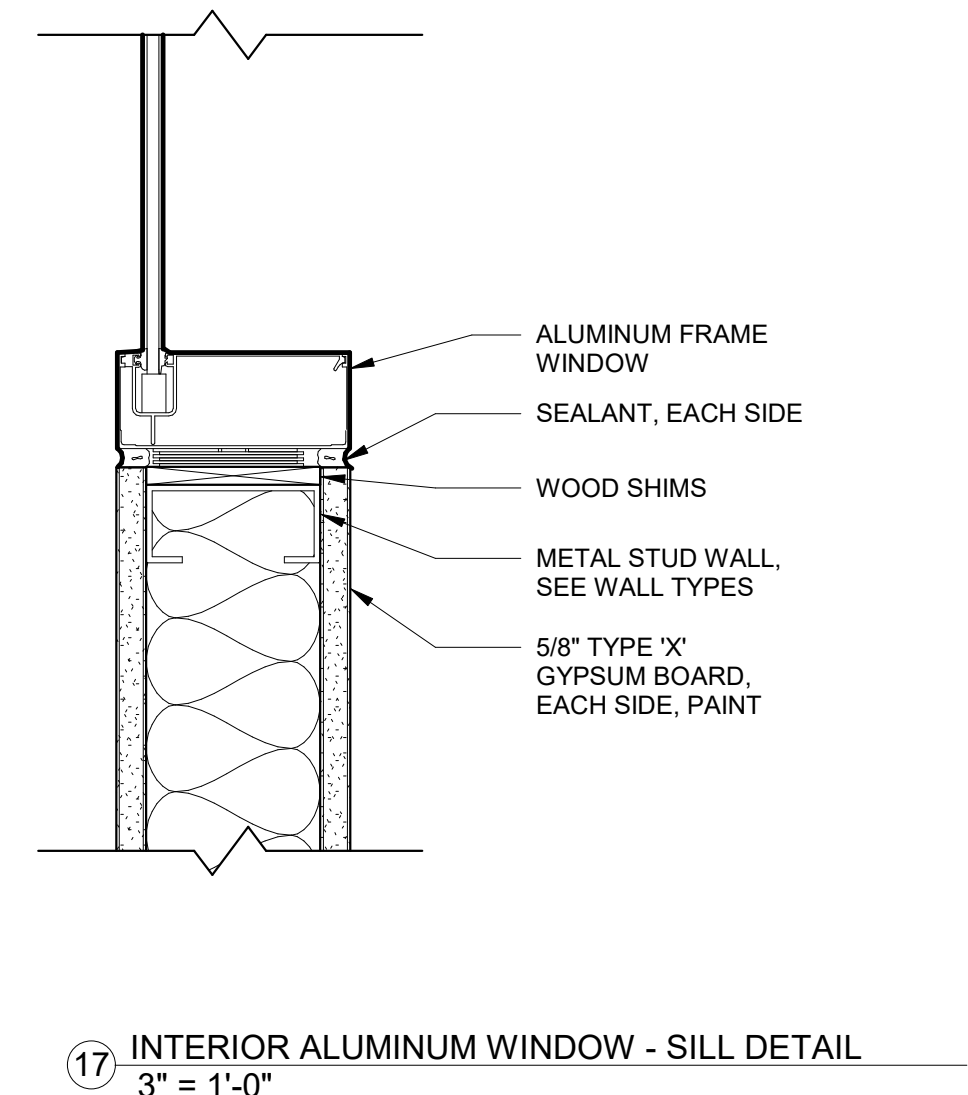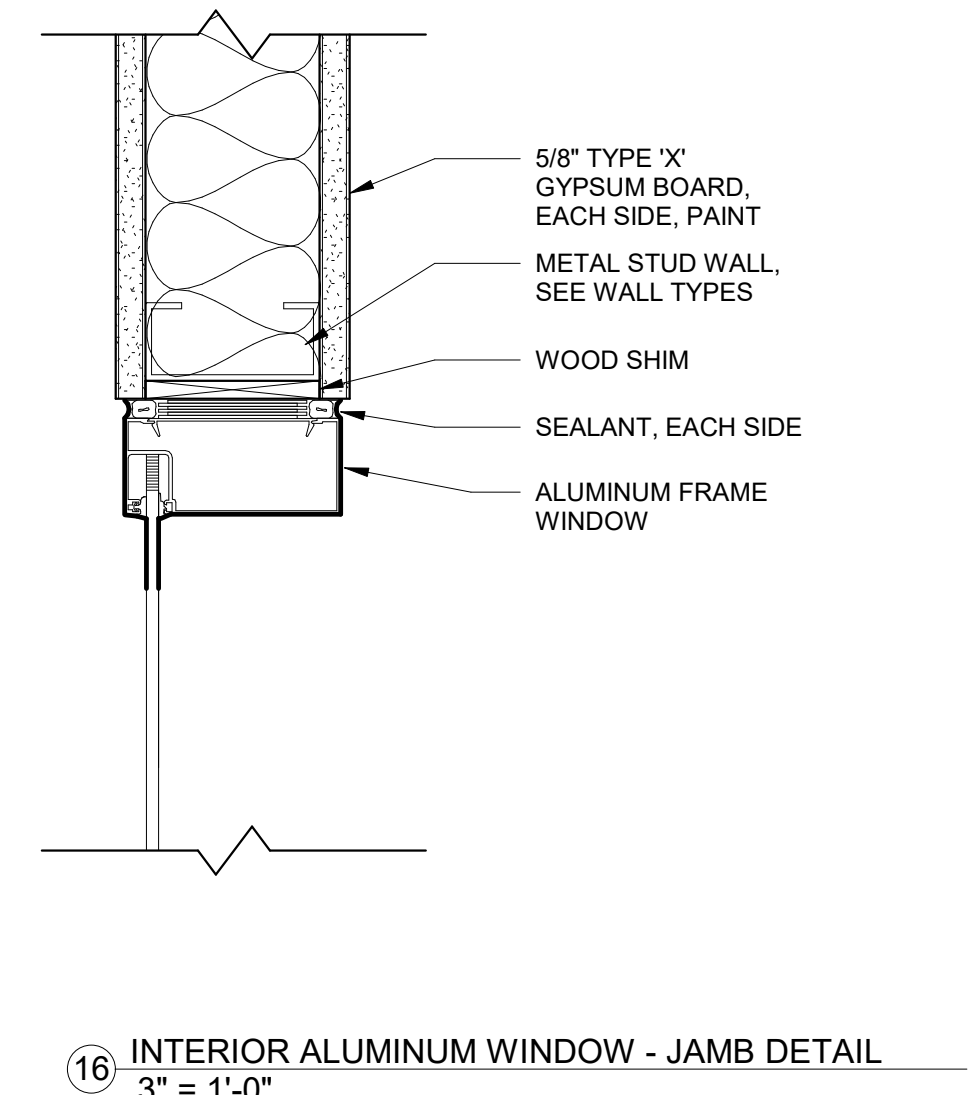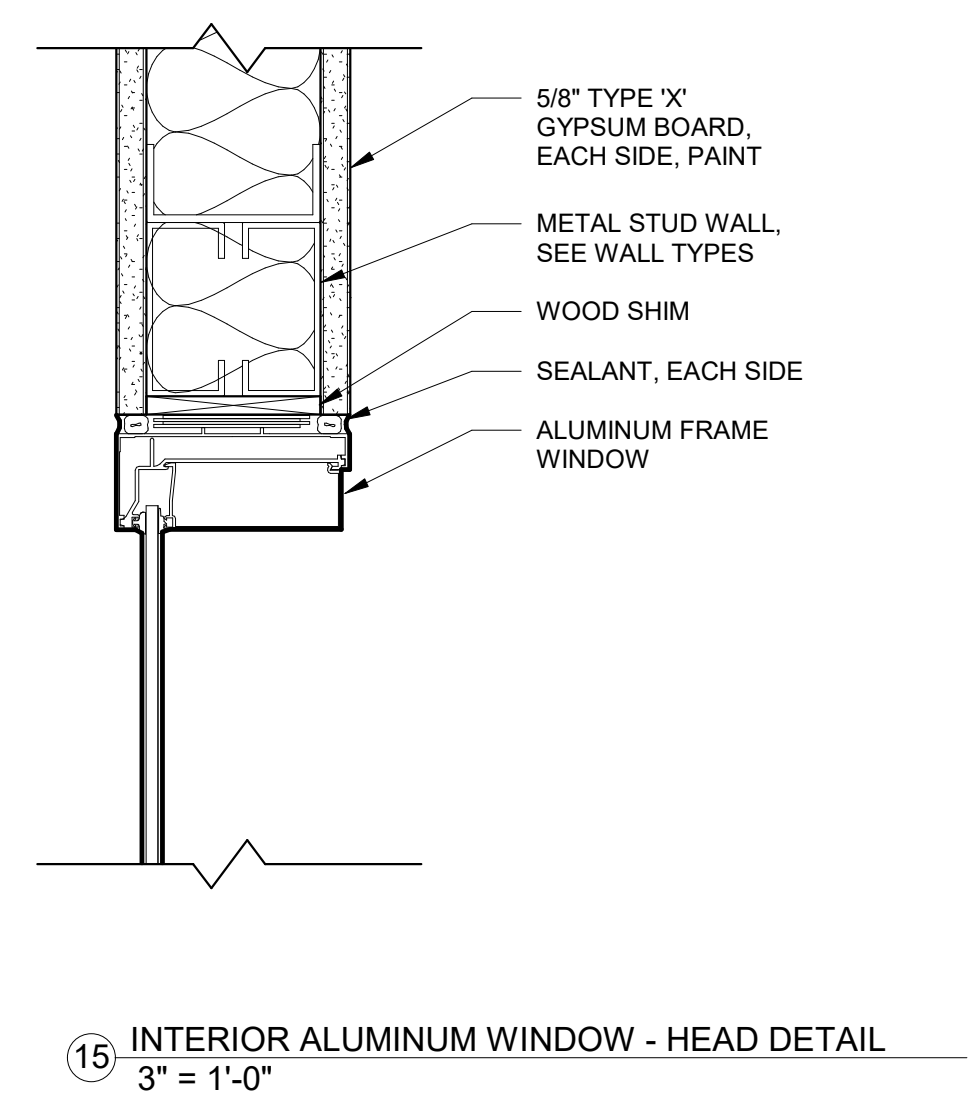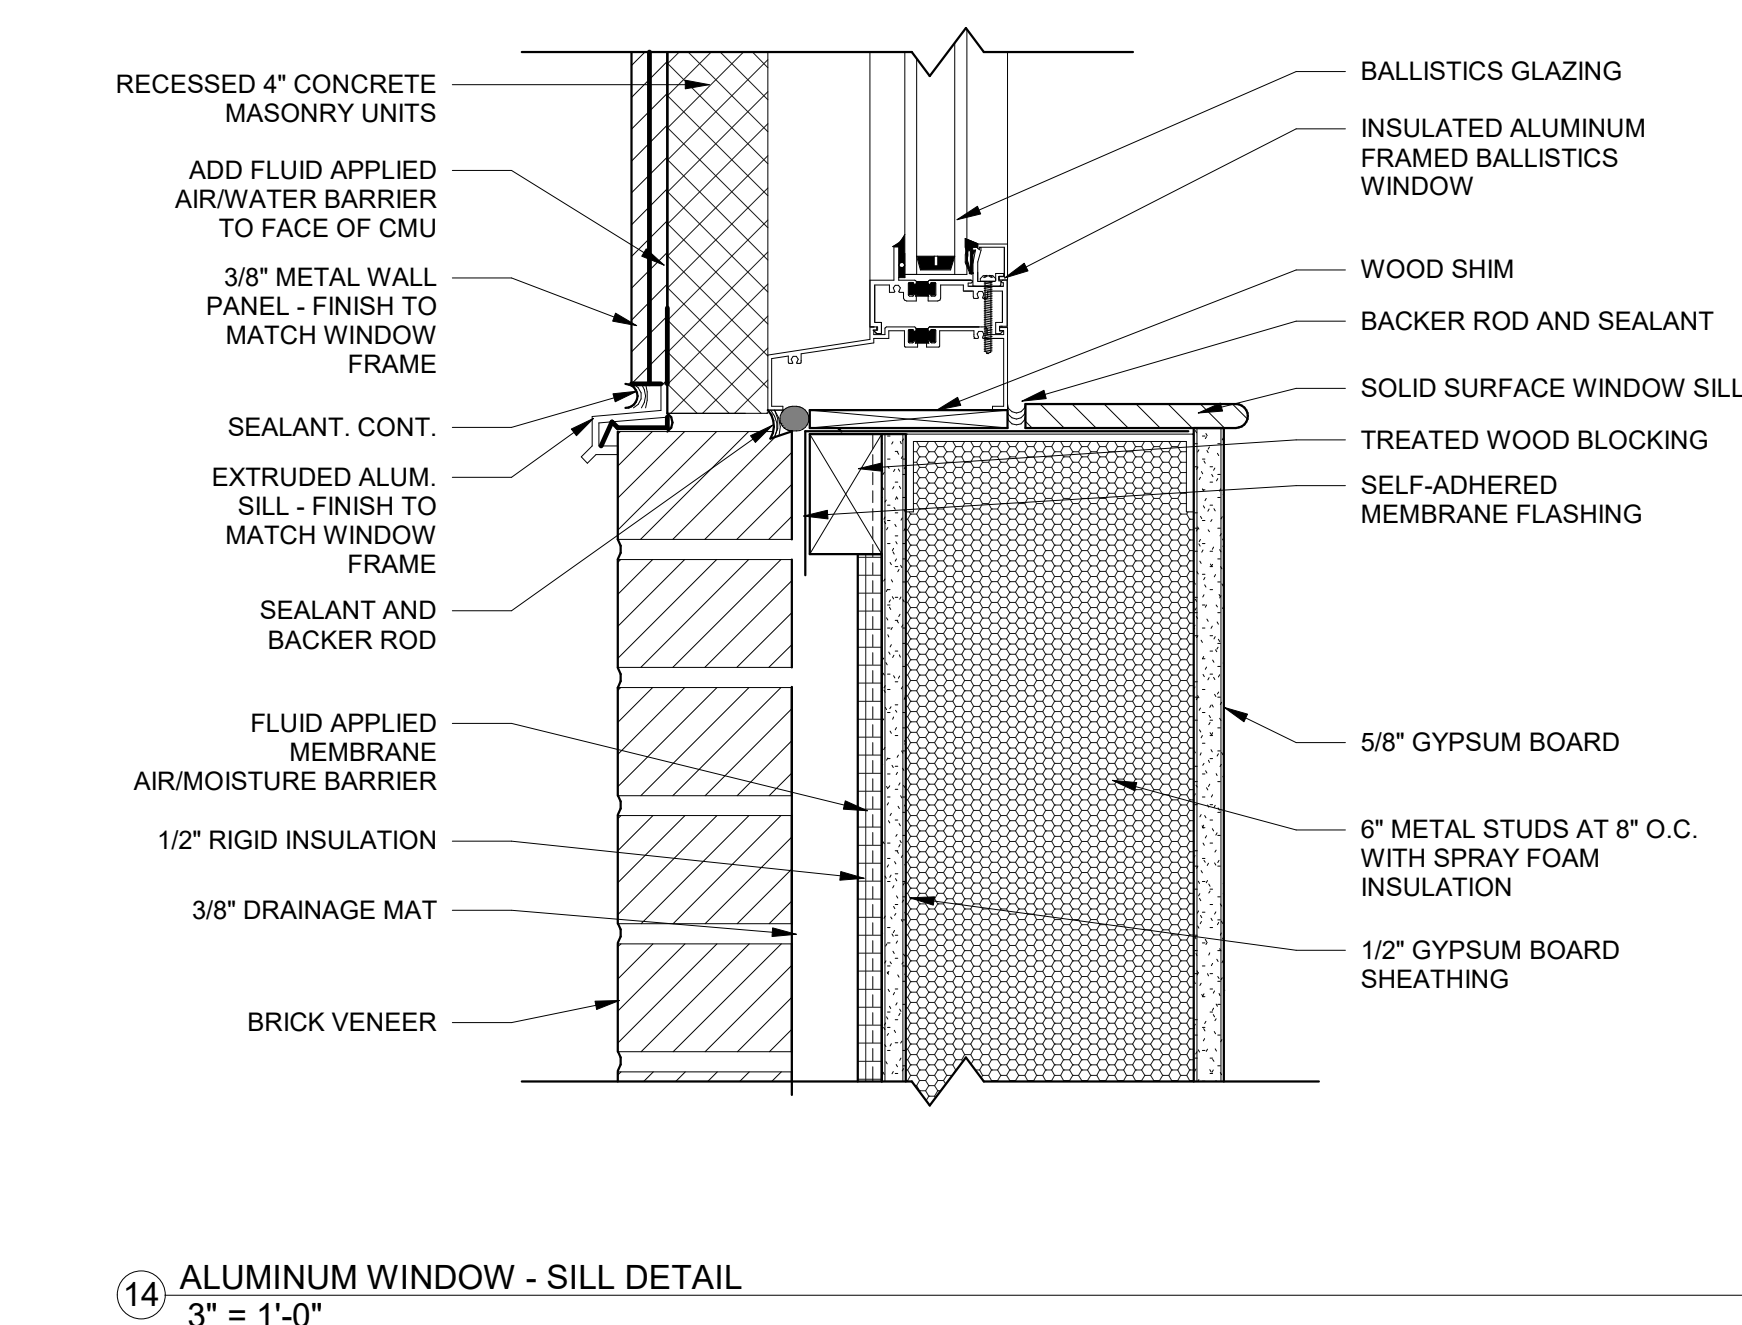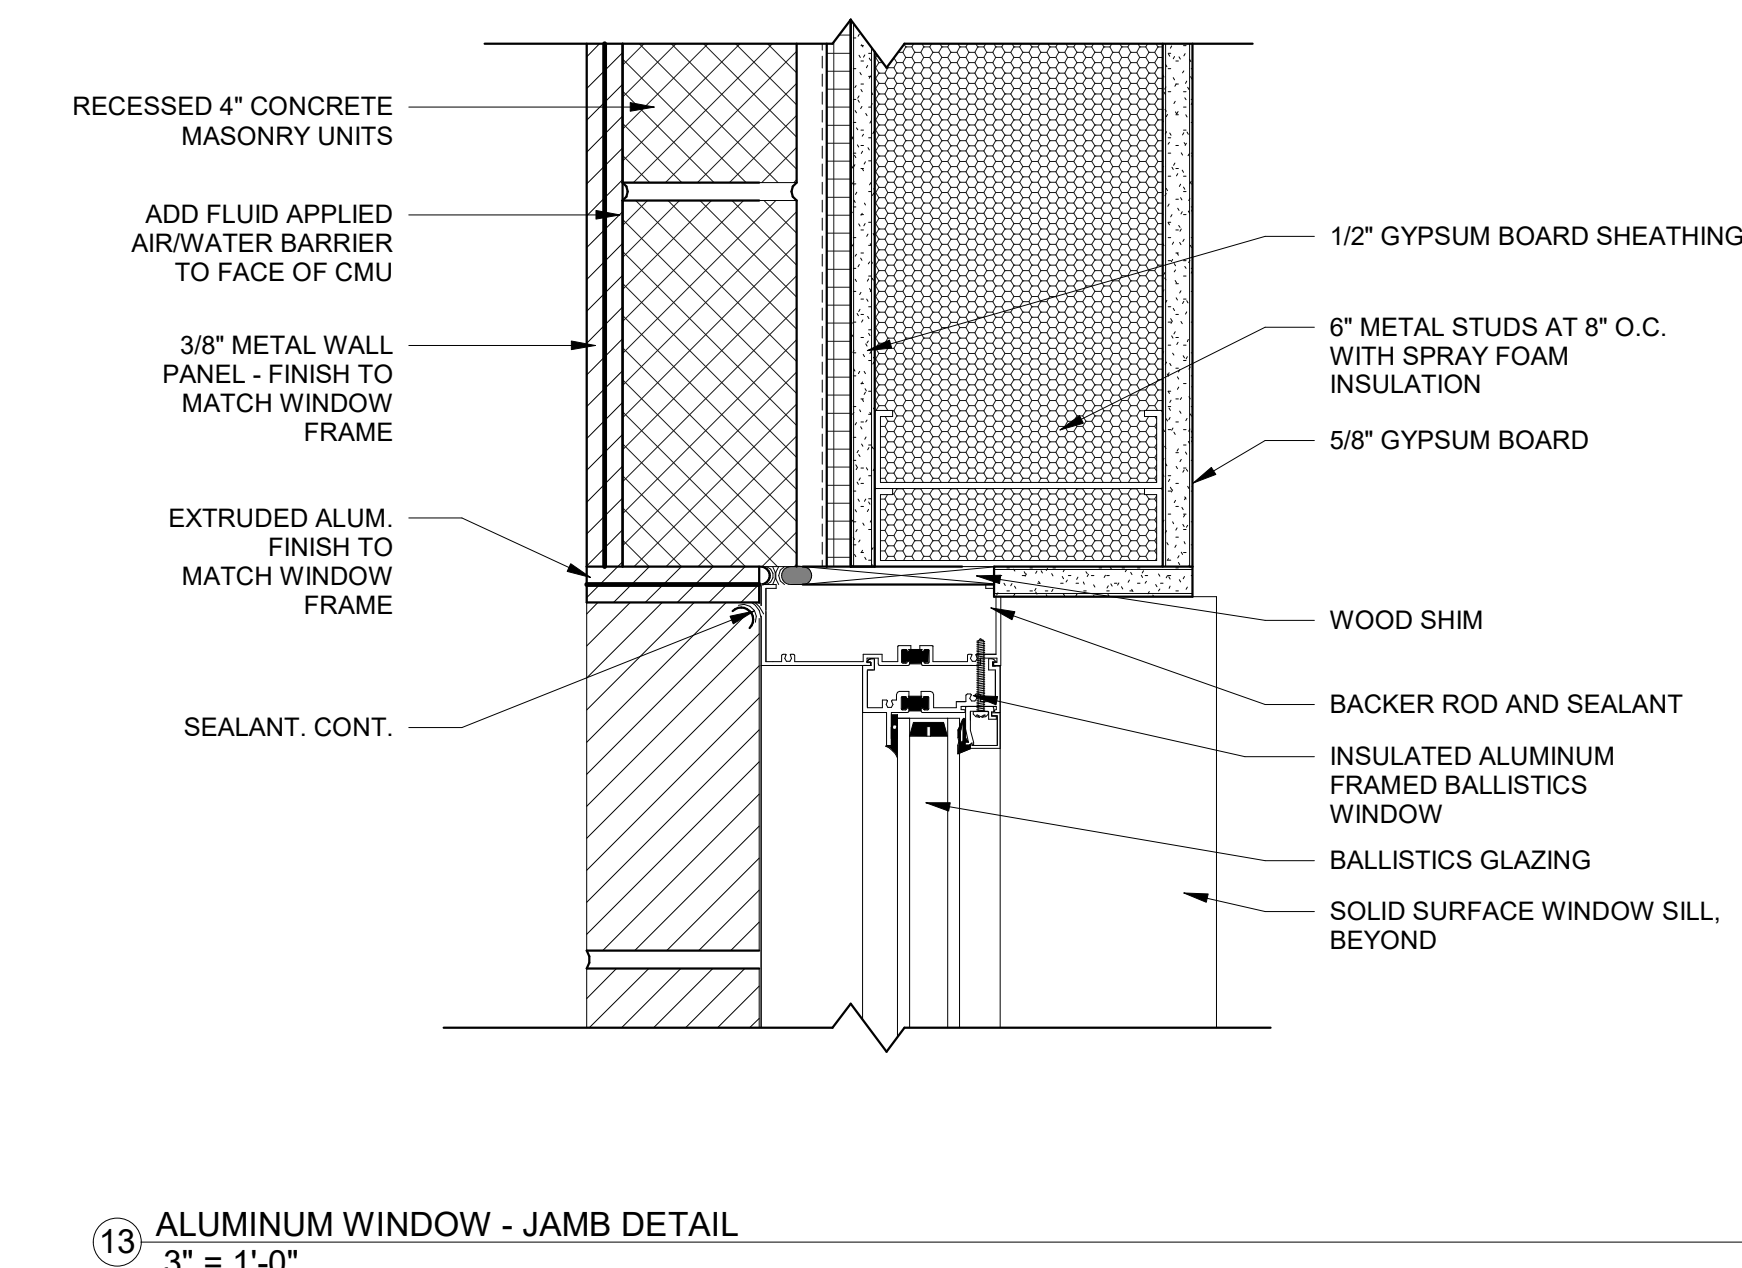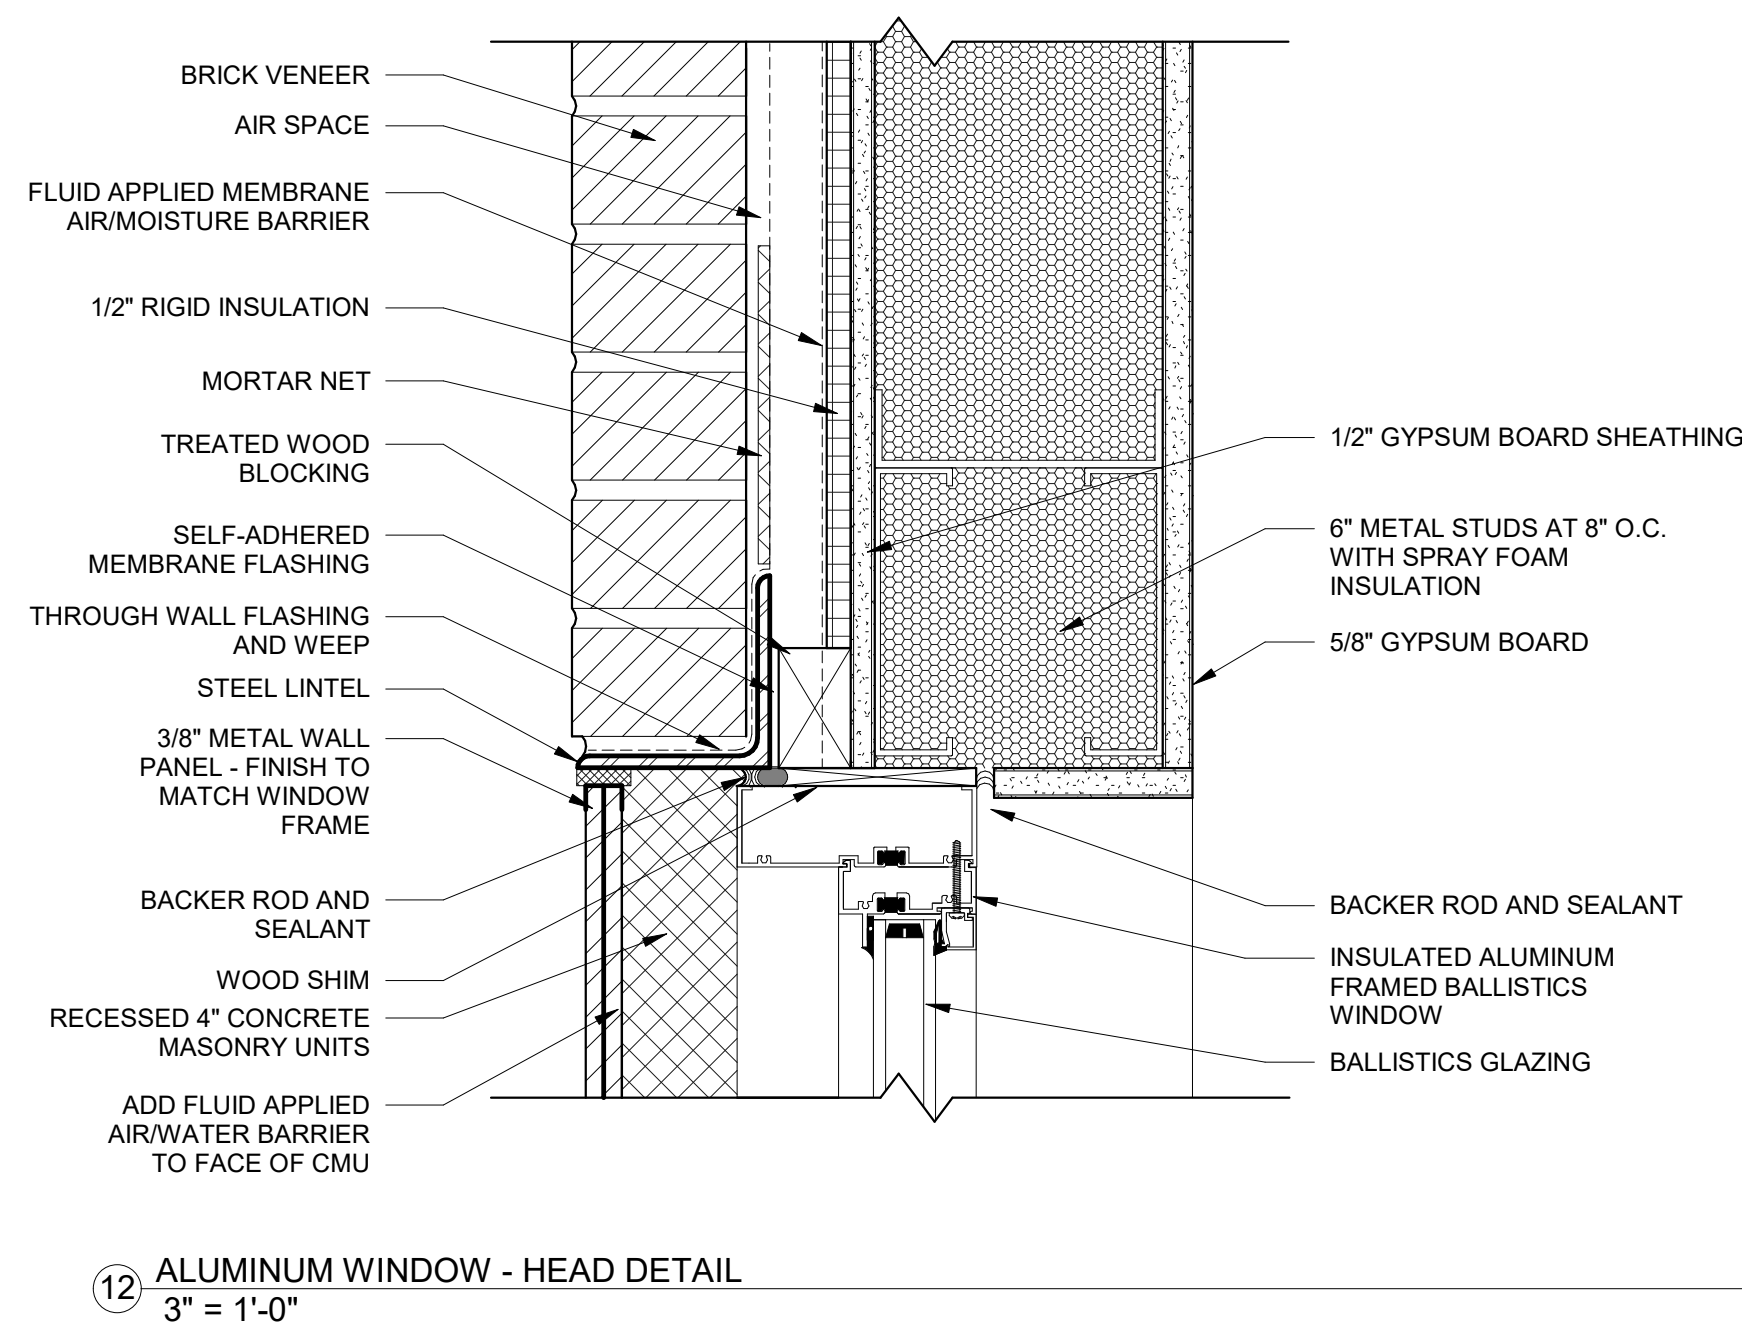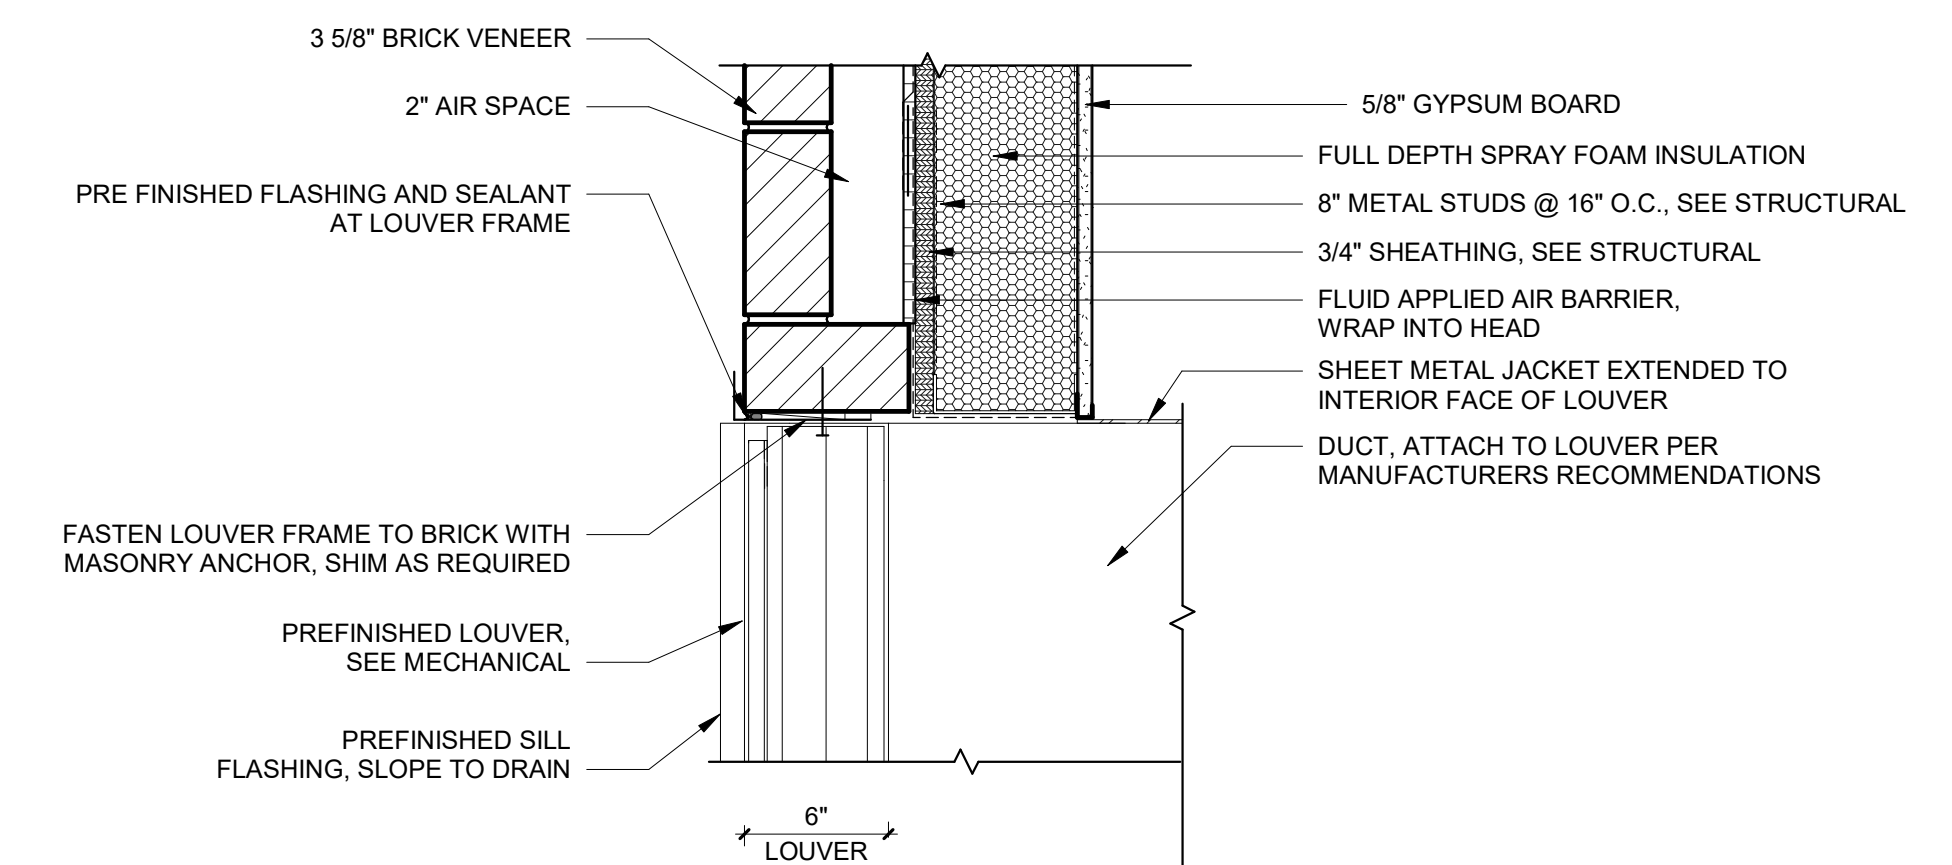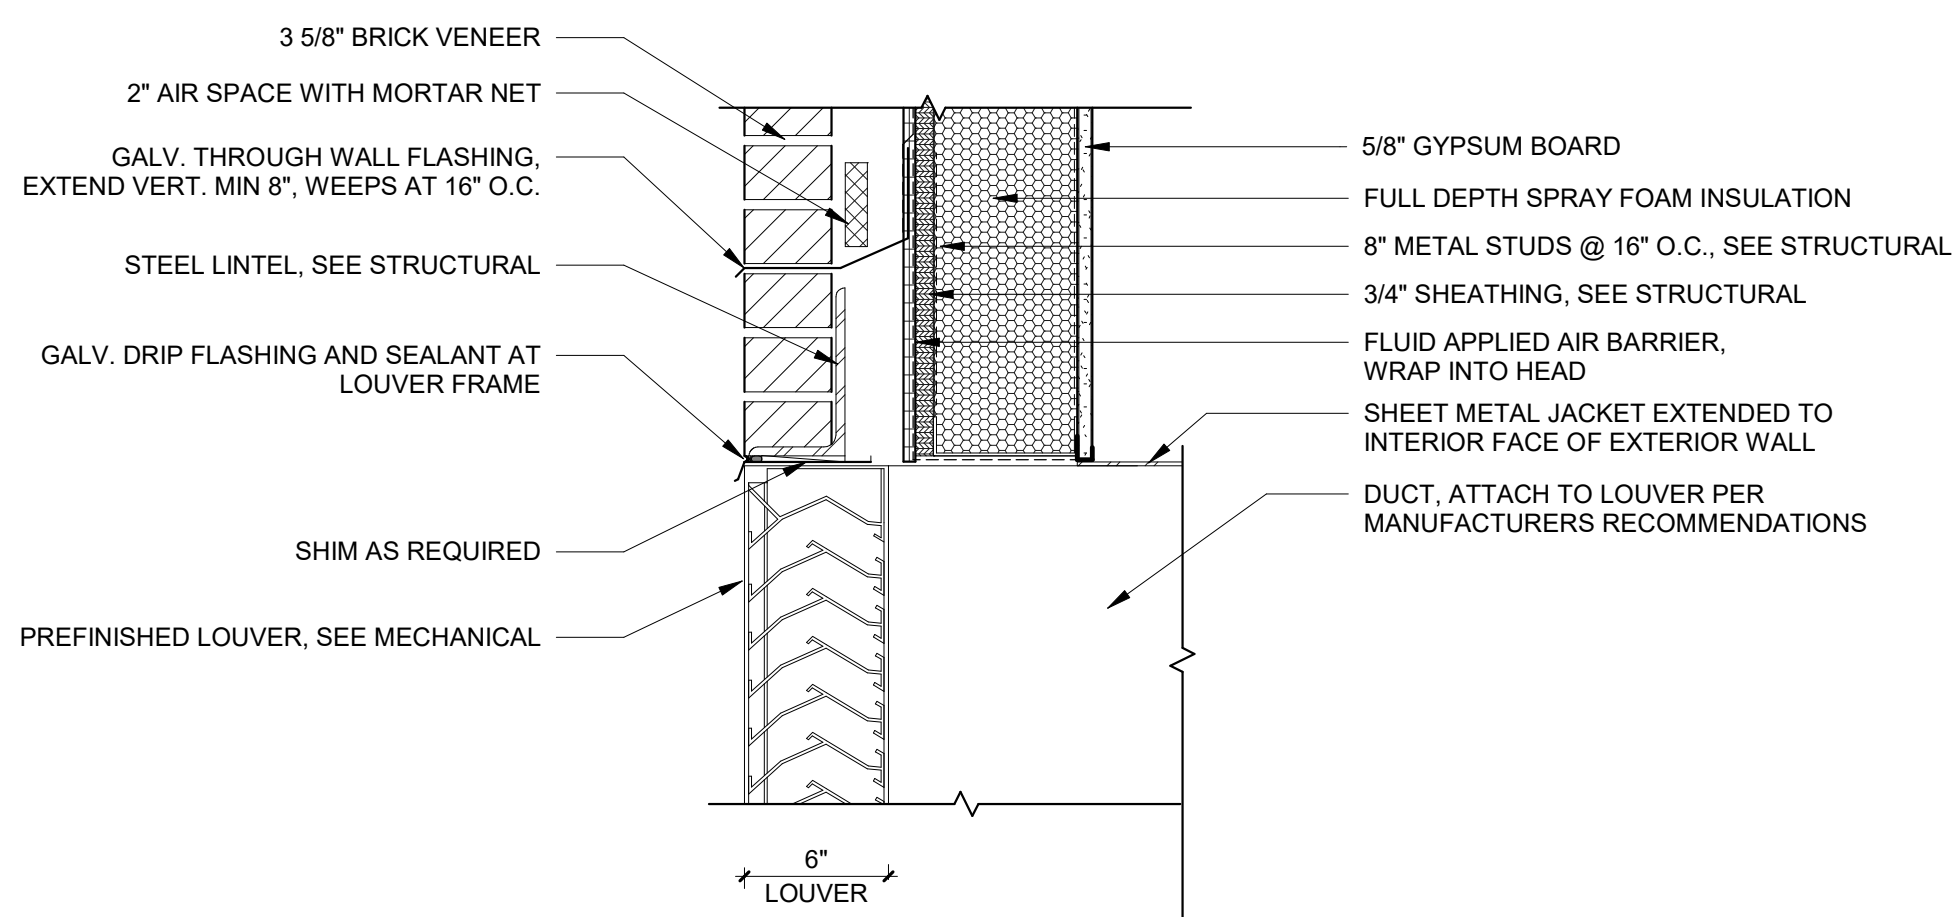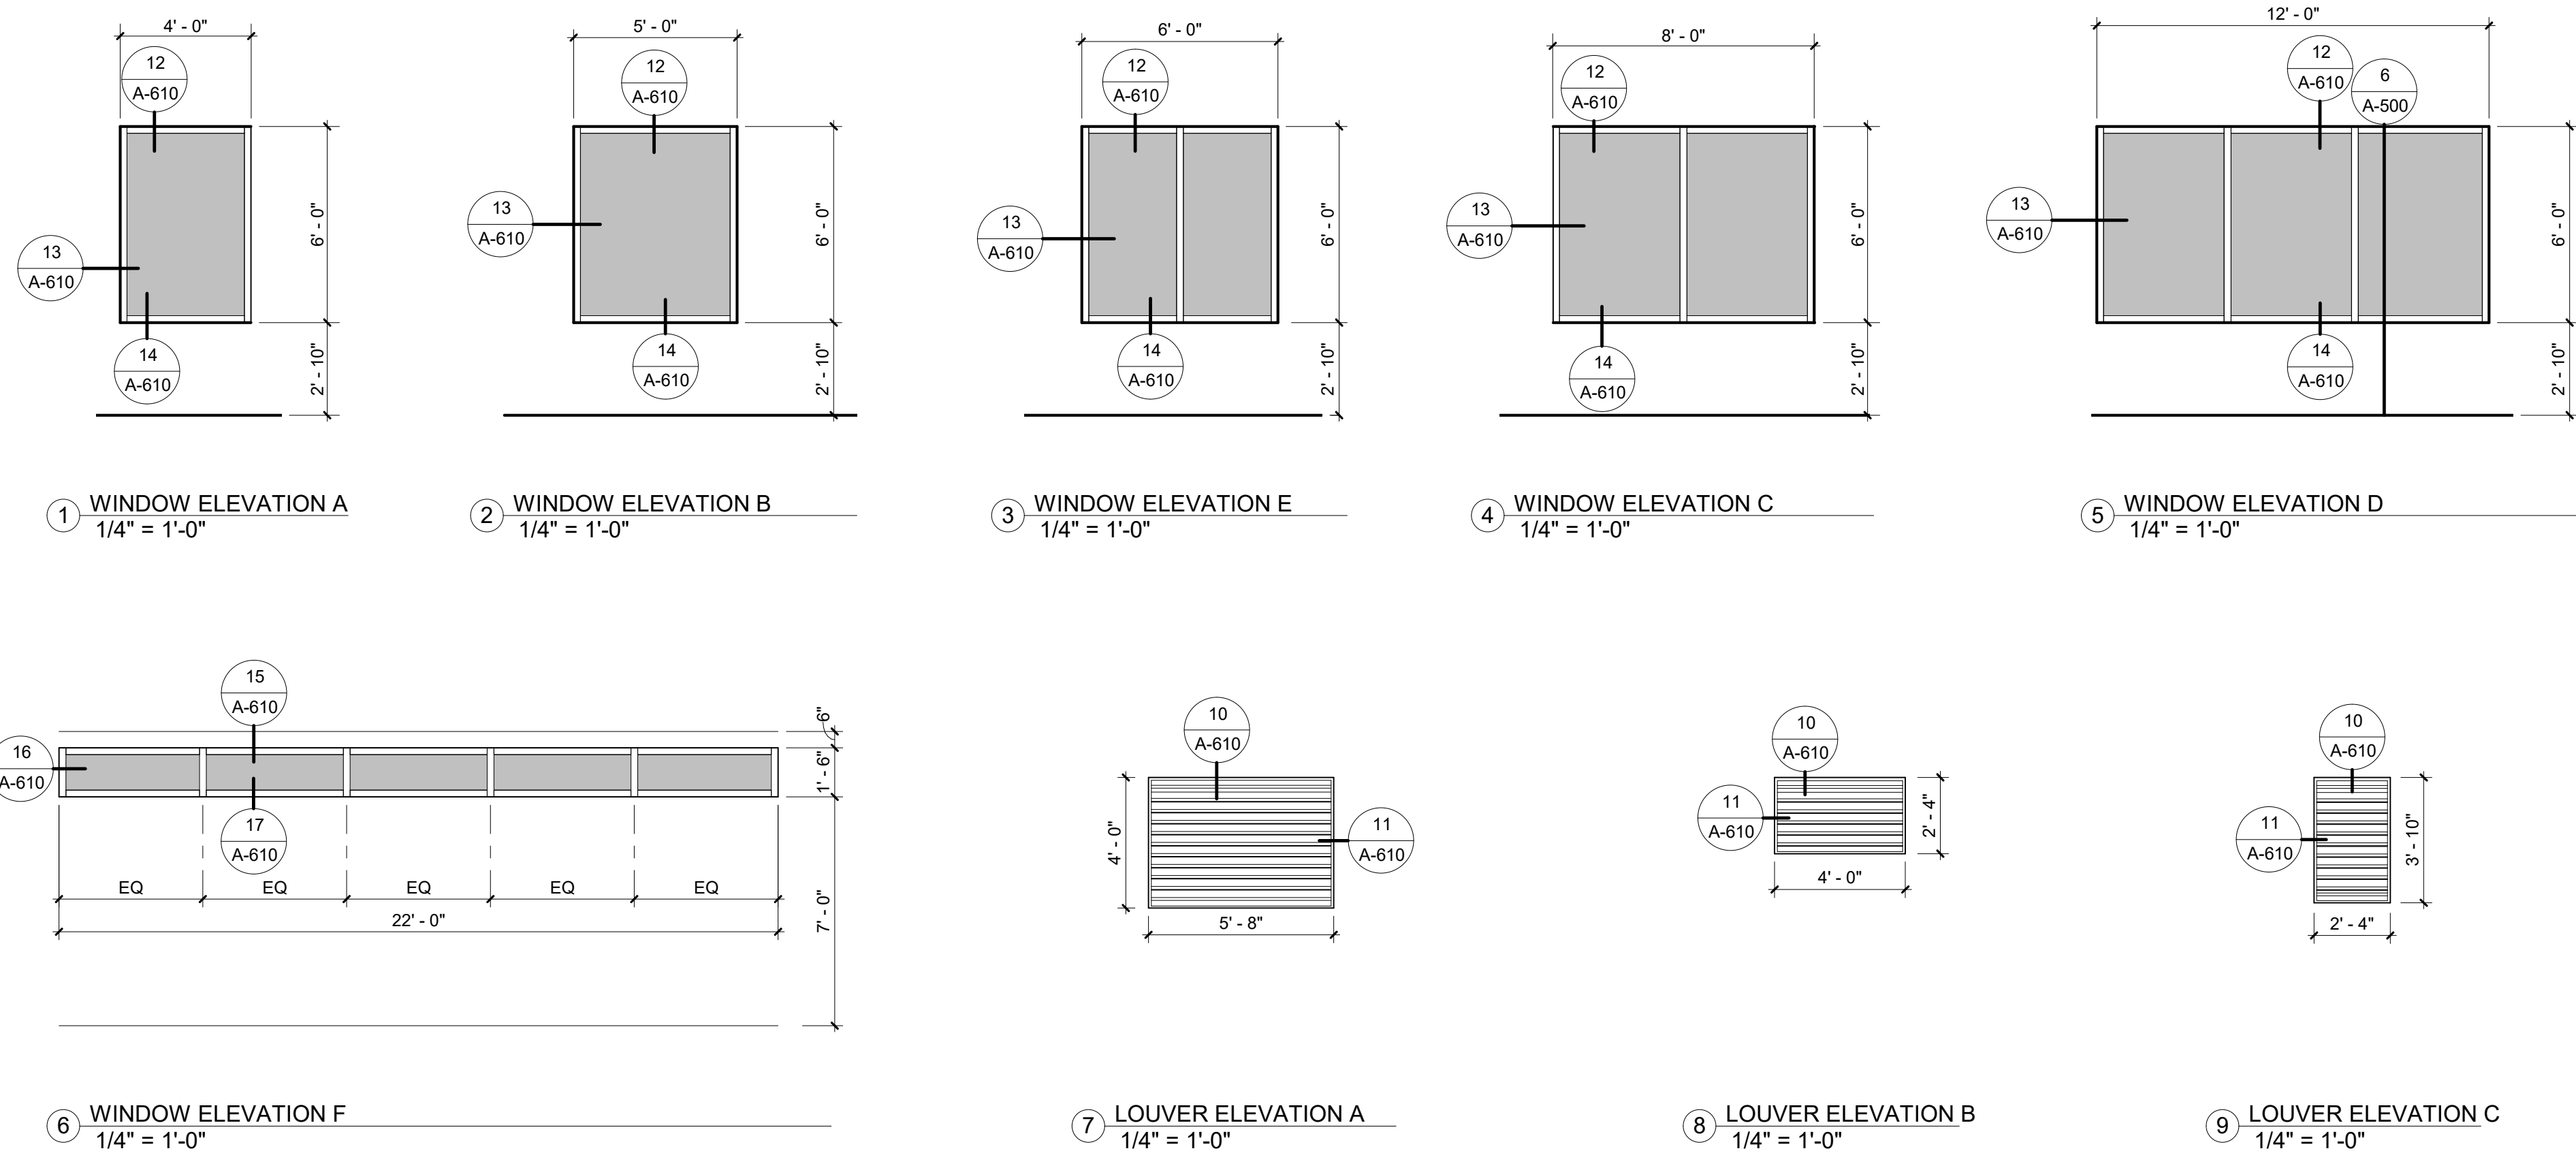1. SHEET SIZE FOR PROPER SCALE IS 30X42. CONTRACTOR SHALL NOT SCALE DRAWINGS BUT SHALL REQUEST THE DESIRED DIMENSIONS FROM THE ARCHITECT.
2. SEE SHEET G-002 FOR GENERAL NOTES.
3. APPLY 1 1/2" THICK FIREPROOFING AT ALL EXPOSED STEEL WITHIN INTERSTITIAL SPACE AND AT EXPOSED STEEL STRUCTURE ABOVE 3RD FLOOR CEILING, TYP.




CONSTRUCTION DOCUMENTS


		CONSULTANTS:				ARCHITECT				Drawing Title		Project Title		Project Number		Office of Construction and Facilities Management			
		 TERRASITE DESIGN 1635 DEADWOOD AVENUE RAPID CITY, SOUTH DAKOTA 57202 PH: (605) 791-1736		 Albertson Engineering Inc.		ALBERTSON ENGINEERING, INC. 315 NORTH MAIN AVENUE, SUITE 200 SIOUX FALLS, SOUTH DAKOTA 57104 PH: (605) 274-0880		 FOURFRONT DESIGN, INC. 517 7TH STREET RAPID CITY, SOUTH DAKOTA 57701 PH: (605) 342-9470 FAX: (605) 342-2377 WWW.FOURFRONTDESIGN.COM		WINDOW ELEVATIONS AND DETAILS		Design/Construct Sterile Processing Service- Omaha VA Medical Center		16.2330.A08		Office of Construction and Facilities Management			
		 FARRIS ENGINEERING OMAHA [BRICK] [REIN] [CONCRETE] [MASONRY] FARRIS ENGINEERING OMAHA, NEBRASKA 68154 PH: (402) 330-5900				FARRIS ENGINEERING 12700 WEST DODGE ROAD OMAHA, NEBRASKA 68154 PH: (402) 330-5900				Approved: Project Director Omaha VA Medical Center		Location 4101 Woolworth Ave #4199 Omaha, Ne 68105		Drawing Number		A-610		Department of Veterans Affairs	
COMPLIANCE REVIEW INCLUDED		2/23/2024										Date 11/23/2020		Checked JL		Drawn JGC		Dwg. 79 of 193	
Revisions:		Date																	

GENERAL NOTES:

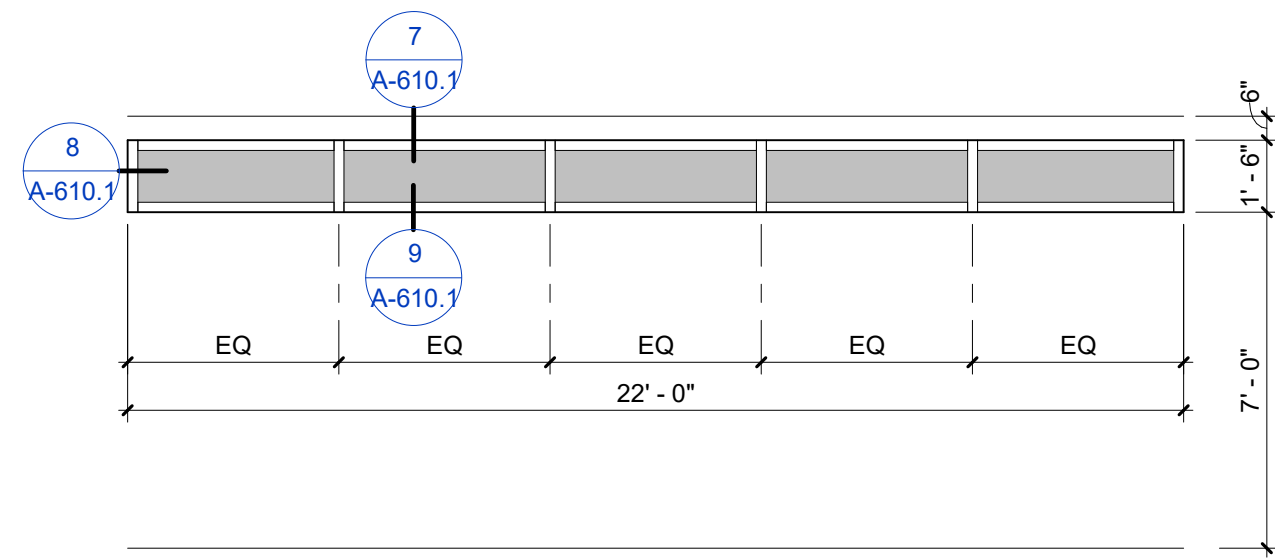
1. SHEET SIZE FOR PROPER SCALE IS 30X42. CONTRACTOR SHALL NOT SCALE DRAWINGS BUT SHALL REQUEST THE DESIRED DIMENSIONS FROM THE ARCHITECT.
2. SEE SHEET G-002 FOR GENERAL NOTES
3. APPLY 1 1/2" THICK FIREPROOFING AT ALL EXPOSED STEEL WITHIN INTERSTITIAL SPACE AND AT EXPOSED STEEL STRUCTURE ABOVE 3RD FLOOR CEILING, TYP.




1 WINDOW ELEVATION F
1/4" = 1'-0"

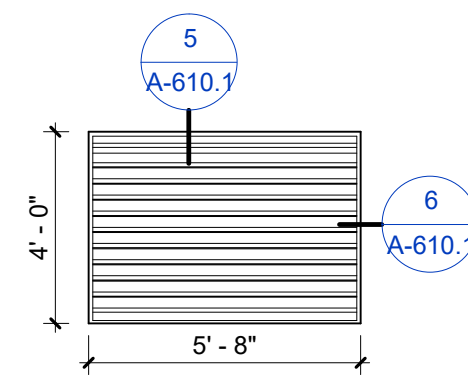


2 LOUVER ELEVATION A
1/4" = 1'-0"

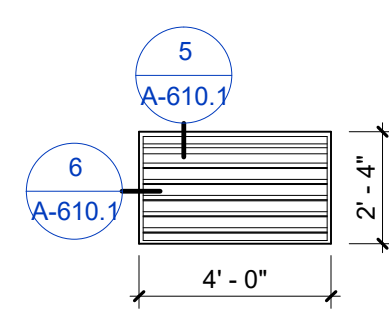


3 LOUVER ELEVATION B
1/4" = 1'-0"

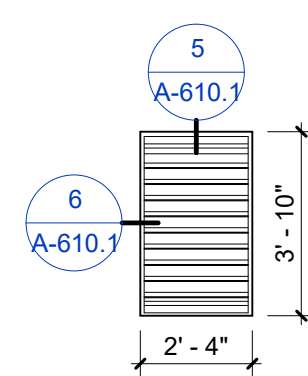


4 LOUVER ELEVATION C
1/4" = 1'-0"

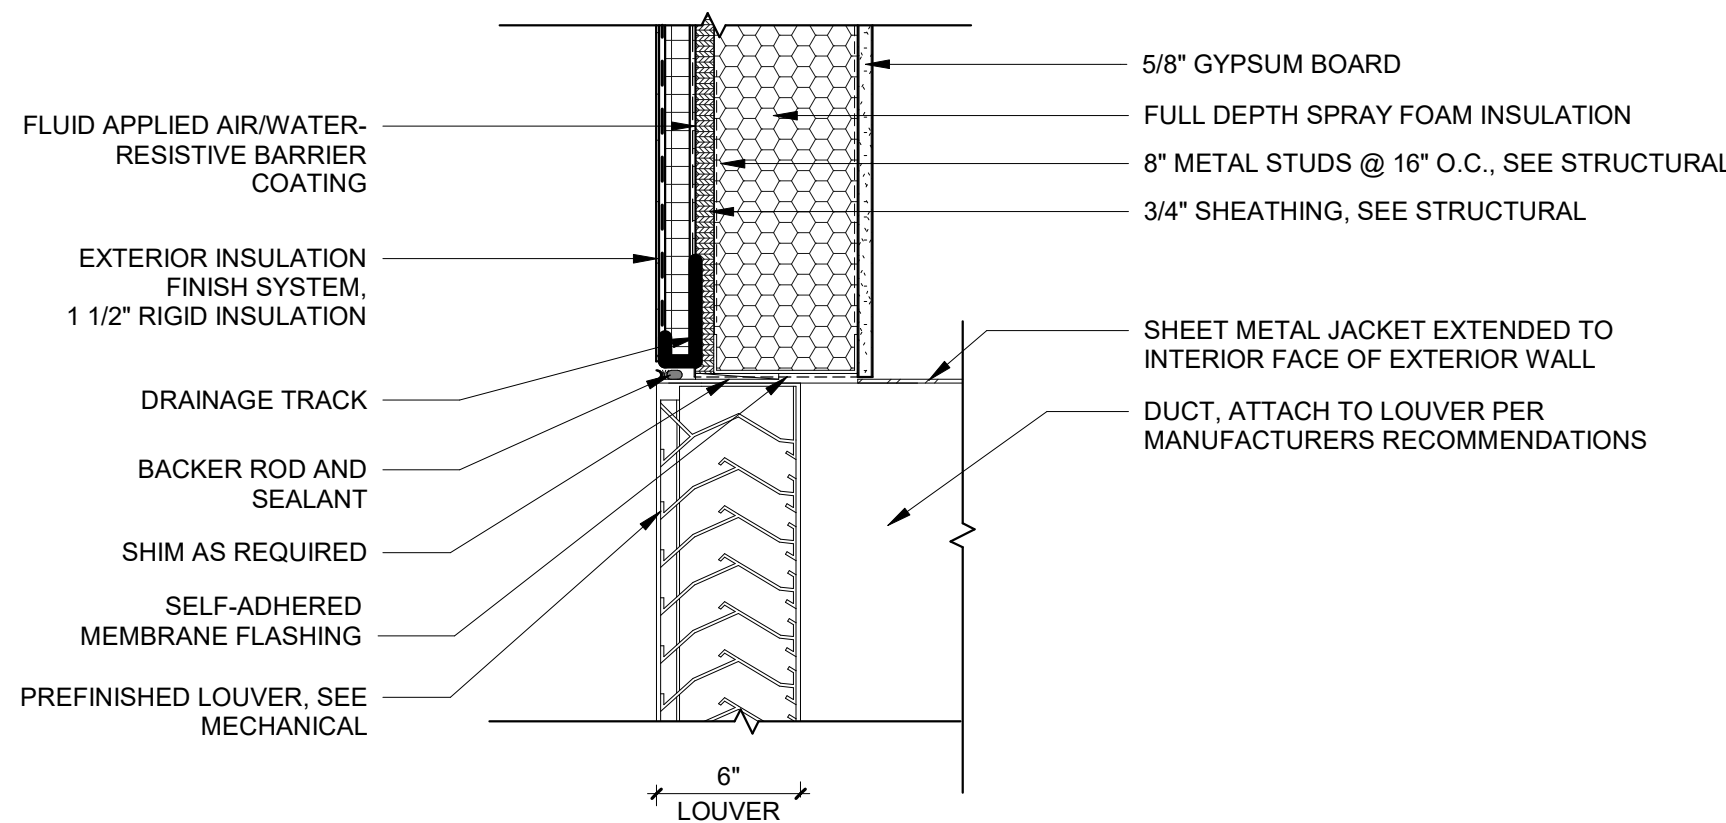


5 LOUVER HEAD DETAIL
1 1/2" = 1'-0"

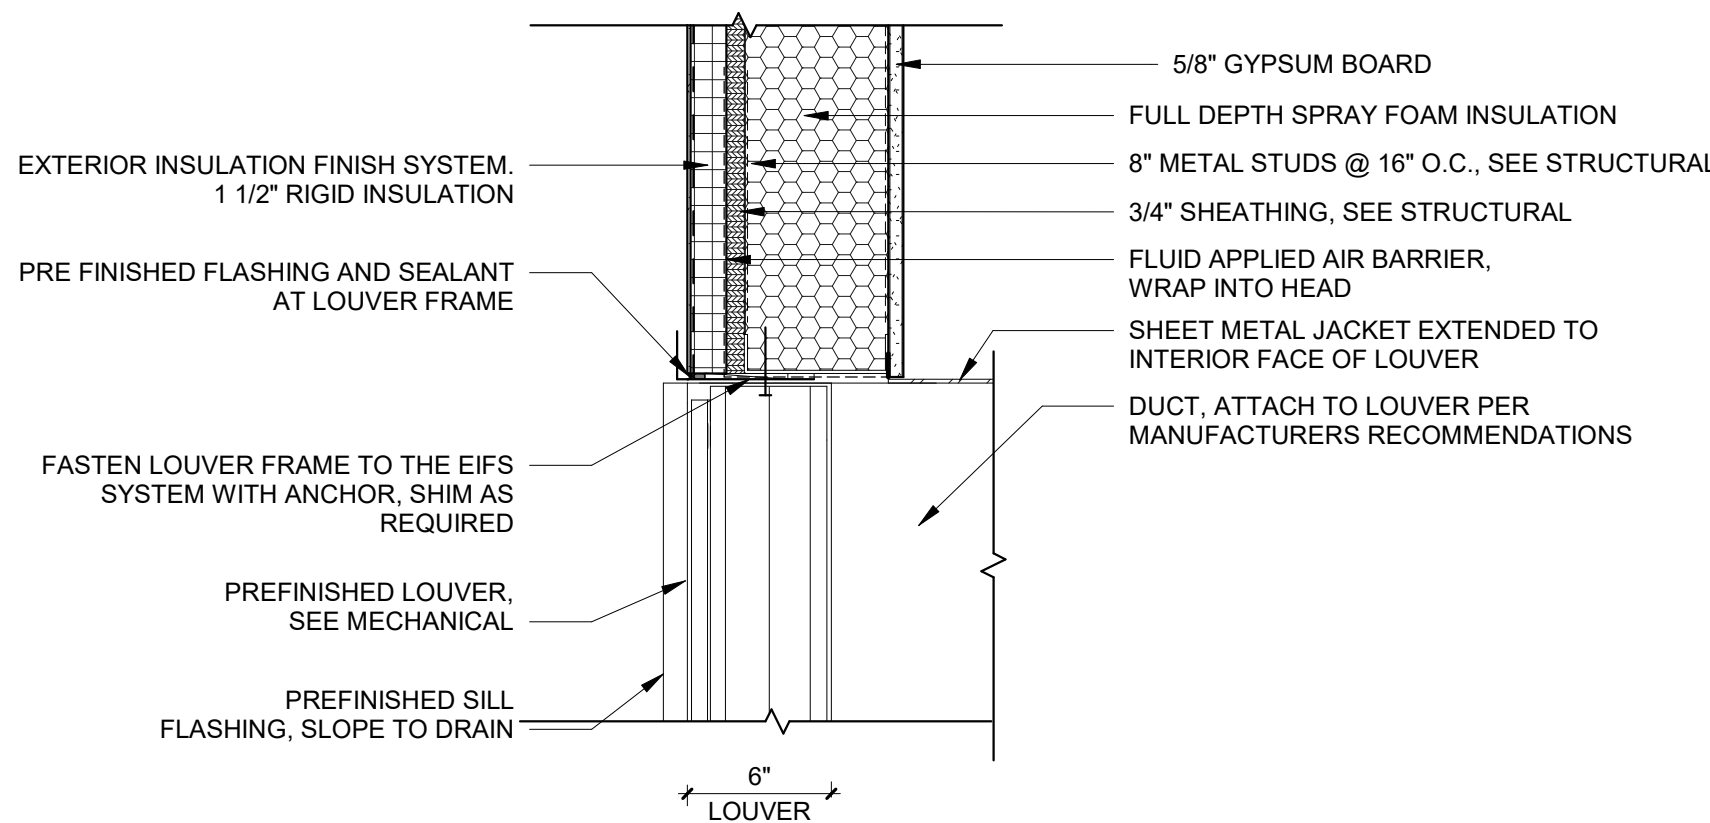


6 LOUVER JAMB DETAIL
1 1/2" = 1'-0"

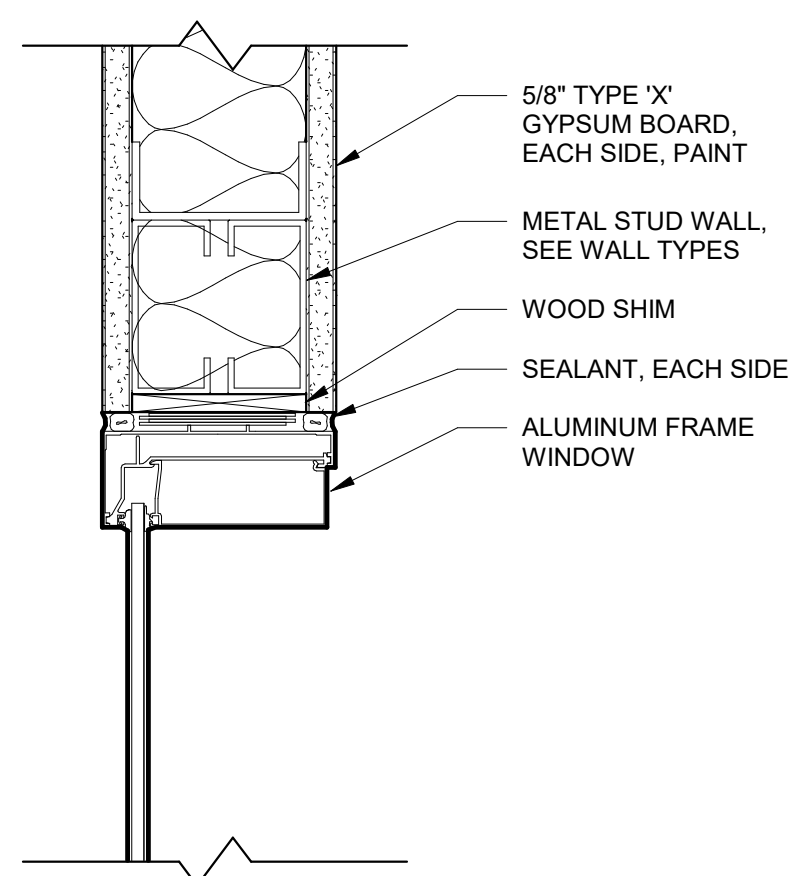

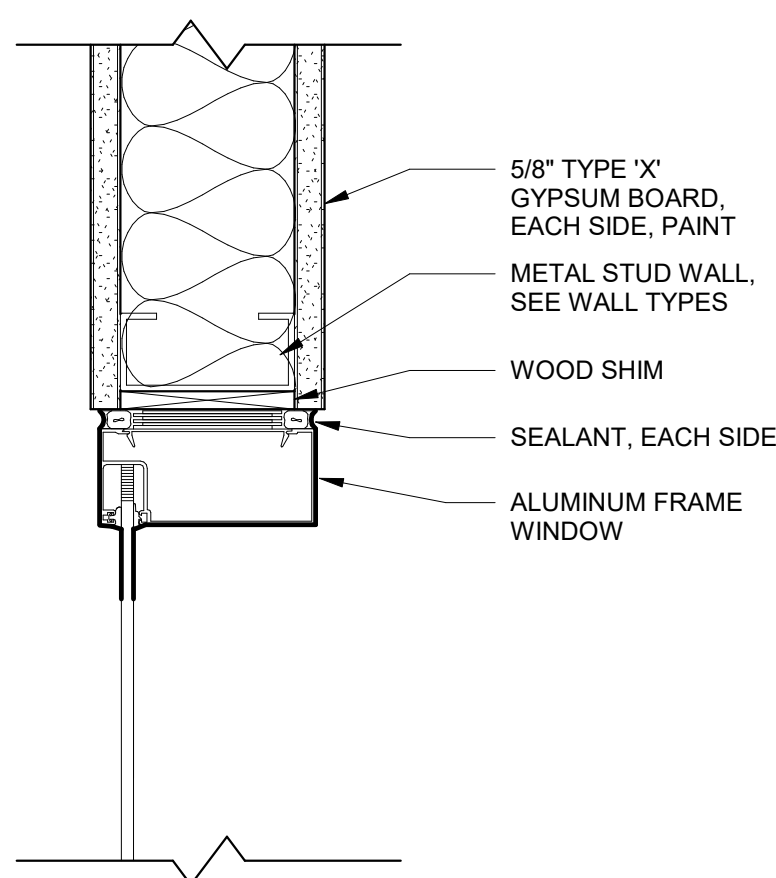7 INTERIOR ALUMINUM WINDOW - HEAD DETAIL
3" = 1'-0"





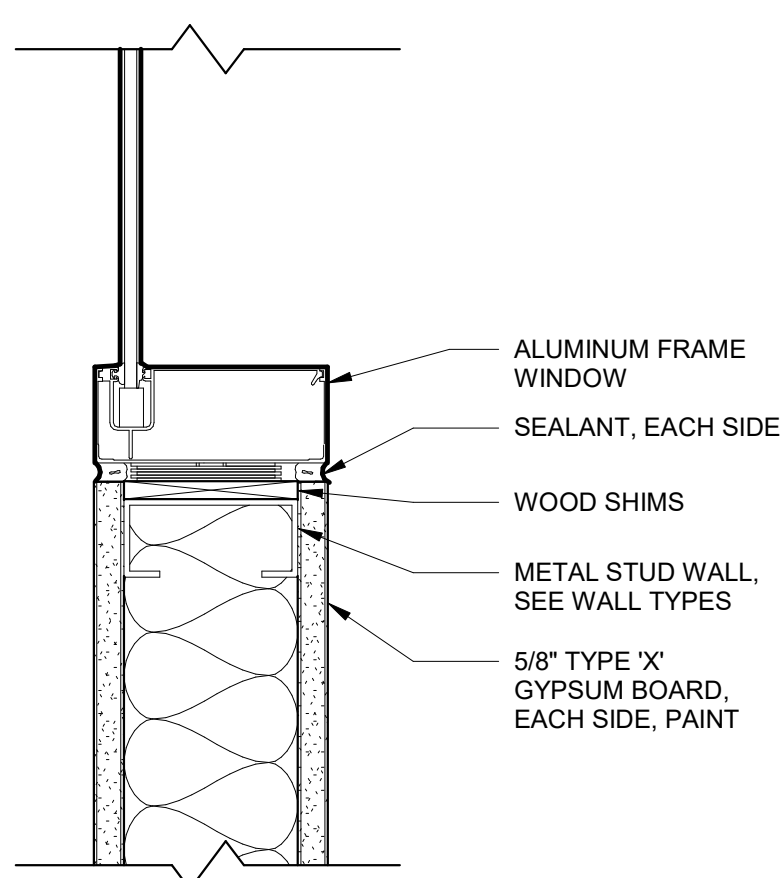8 INTERIOR ALUMINUM WINDOW - JAMB DETAIL
3" = 1'-0"



9 INTERIOR ALUMINUM WINDOW - SILL DETAIL
3" = 1'-0"

  CONSTRUCTION DOCUMENTS

		CONSULTANTS:				ARCHITECT		Drawing Title		Project Title		Project Number		Office of Construction and Facilities Management			
		 Terrasite Design Architectural Landscape Interiors Planning		 Albertson Engineering Inc.		 FARRIS ENGINEERING OMAHA BRANCO BENTLEY COLORADO SPRINGS KANSAS CITY NEW YORK PHOENIX		 FOURFRONT DESIGN INC.		WINDOW ELEVATIONS AND DETAILS - ALTERNATIVE BID #2		Design/Construct Sterile Processing Service- Omaha VA Medical Center		16.2330.A08		Office of Construction and Facilities Management	
		TERRASITE DESIGN 1635 DEADWOOD AVENUE RAPID CITY, SOUTH DAKOTA 57702 PH: (605) 791-1736		ALBERTSON ENGINEERING, INC. 315 NORTH MAIN AVENUE, SUITE 200 SIOUX FALLS, SOUTH DAKOTA 57104 PH: (605) 274-0880		FARRIS ENGINEERING 12700 WEST DODGE ROAD OMAHA, NEBRASKA 68154 PH: (402) 330-5900				Approved: Project Director Omaha VA Medical Center		Location 4101 Woolworth Ave #4199 Omaha, Ne 68105		Building Number 25			Department of Veterans Affairs
COMPLIANCY REVIEW INCLUDED		2/23/2024								Date 11/23/2020		Checked JL		Drawn JGC		Drawing Number A-610.1	
Revisions:		Date														Dwg. 80 of 193	