




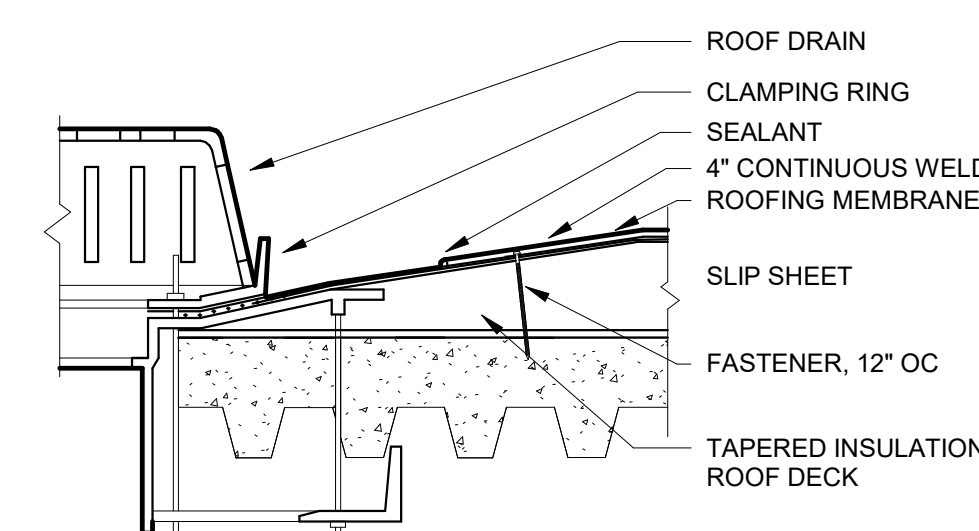


① TYPICAL ROOF DRAIN DETAIL
1 1/2" = 1'-0"

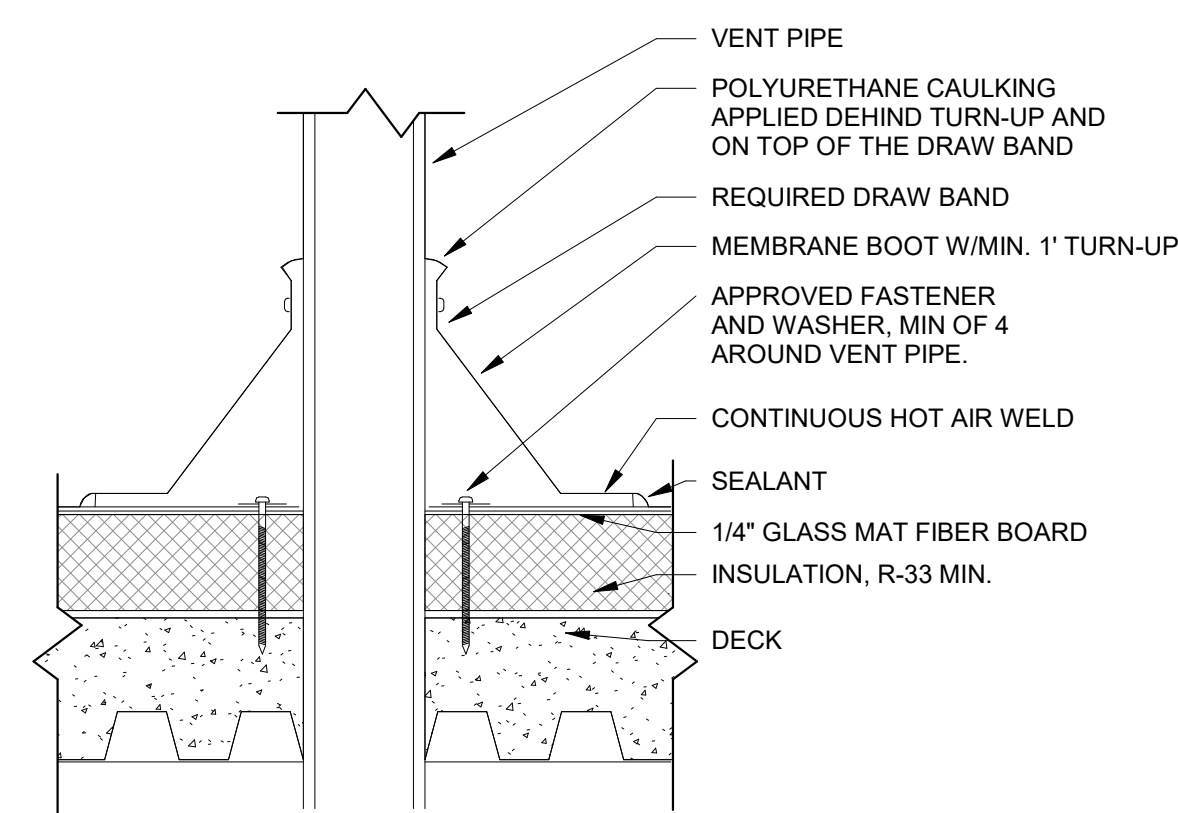


2 TYPICAL THROUGH - ROOF PIPE DETAIL
1 1/2" = 1'-0"

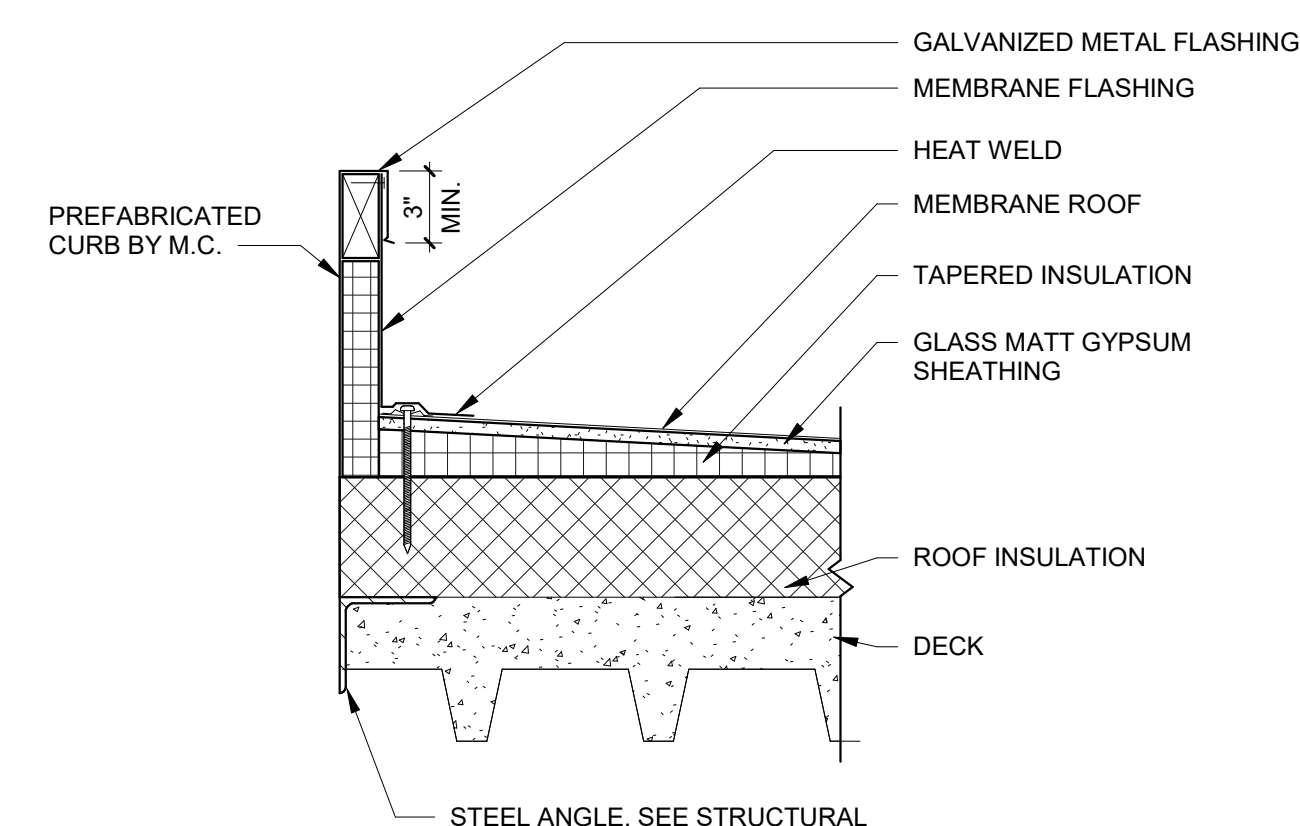


3 ROOF CURB AT MECHANICAL UNIT
1 1/2" = 1'-0"

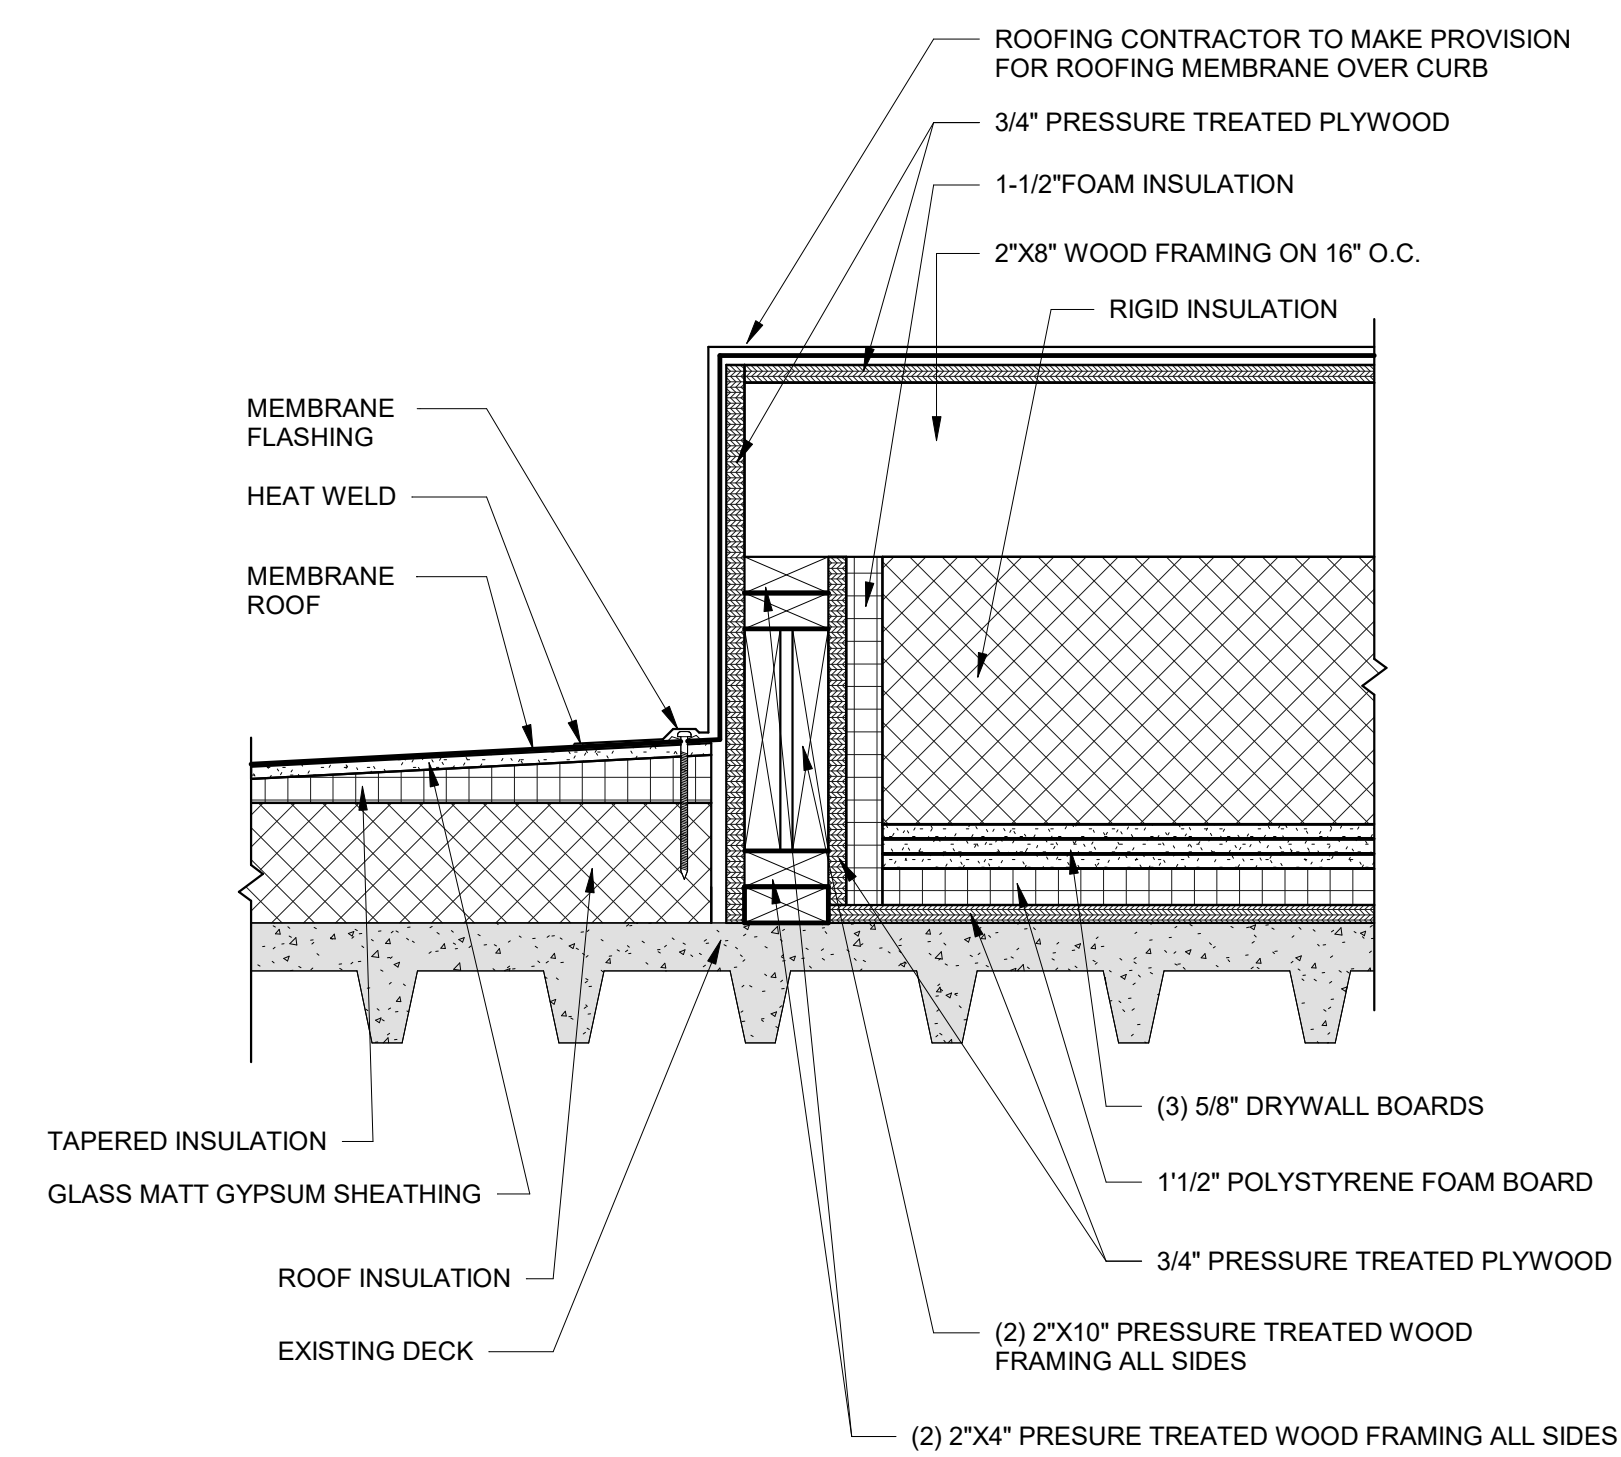


4 CHILLER CURB DETAIL
1 1/2" = 1'-0"

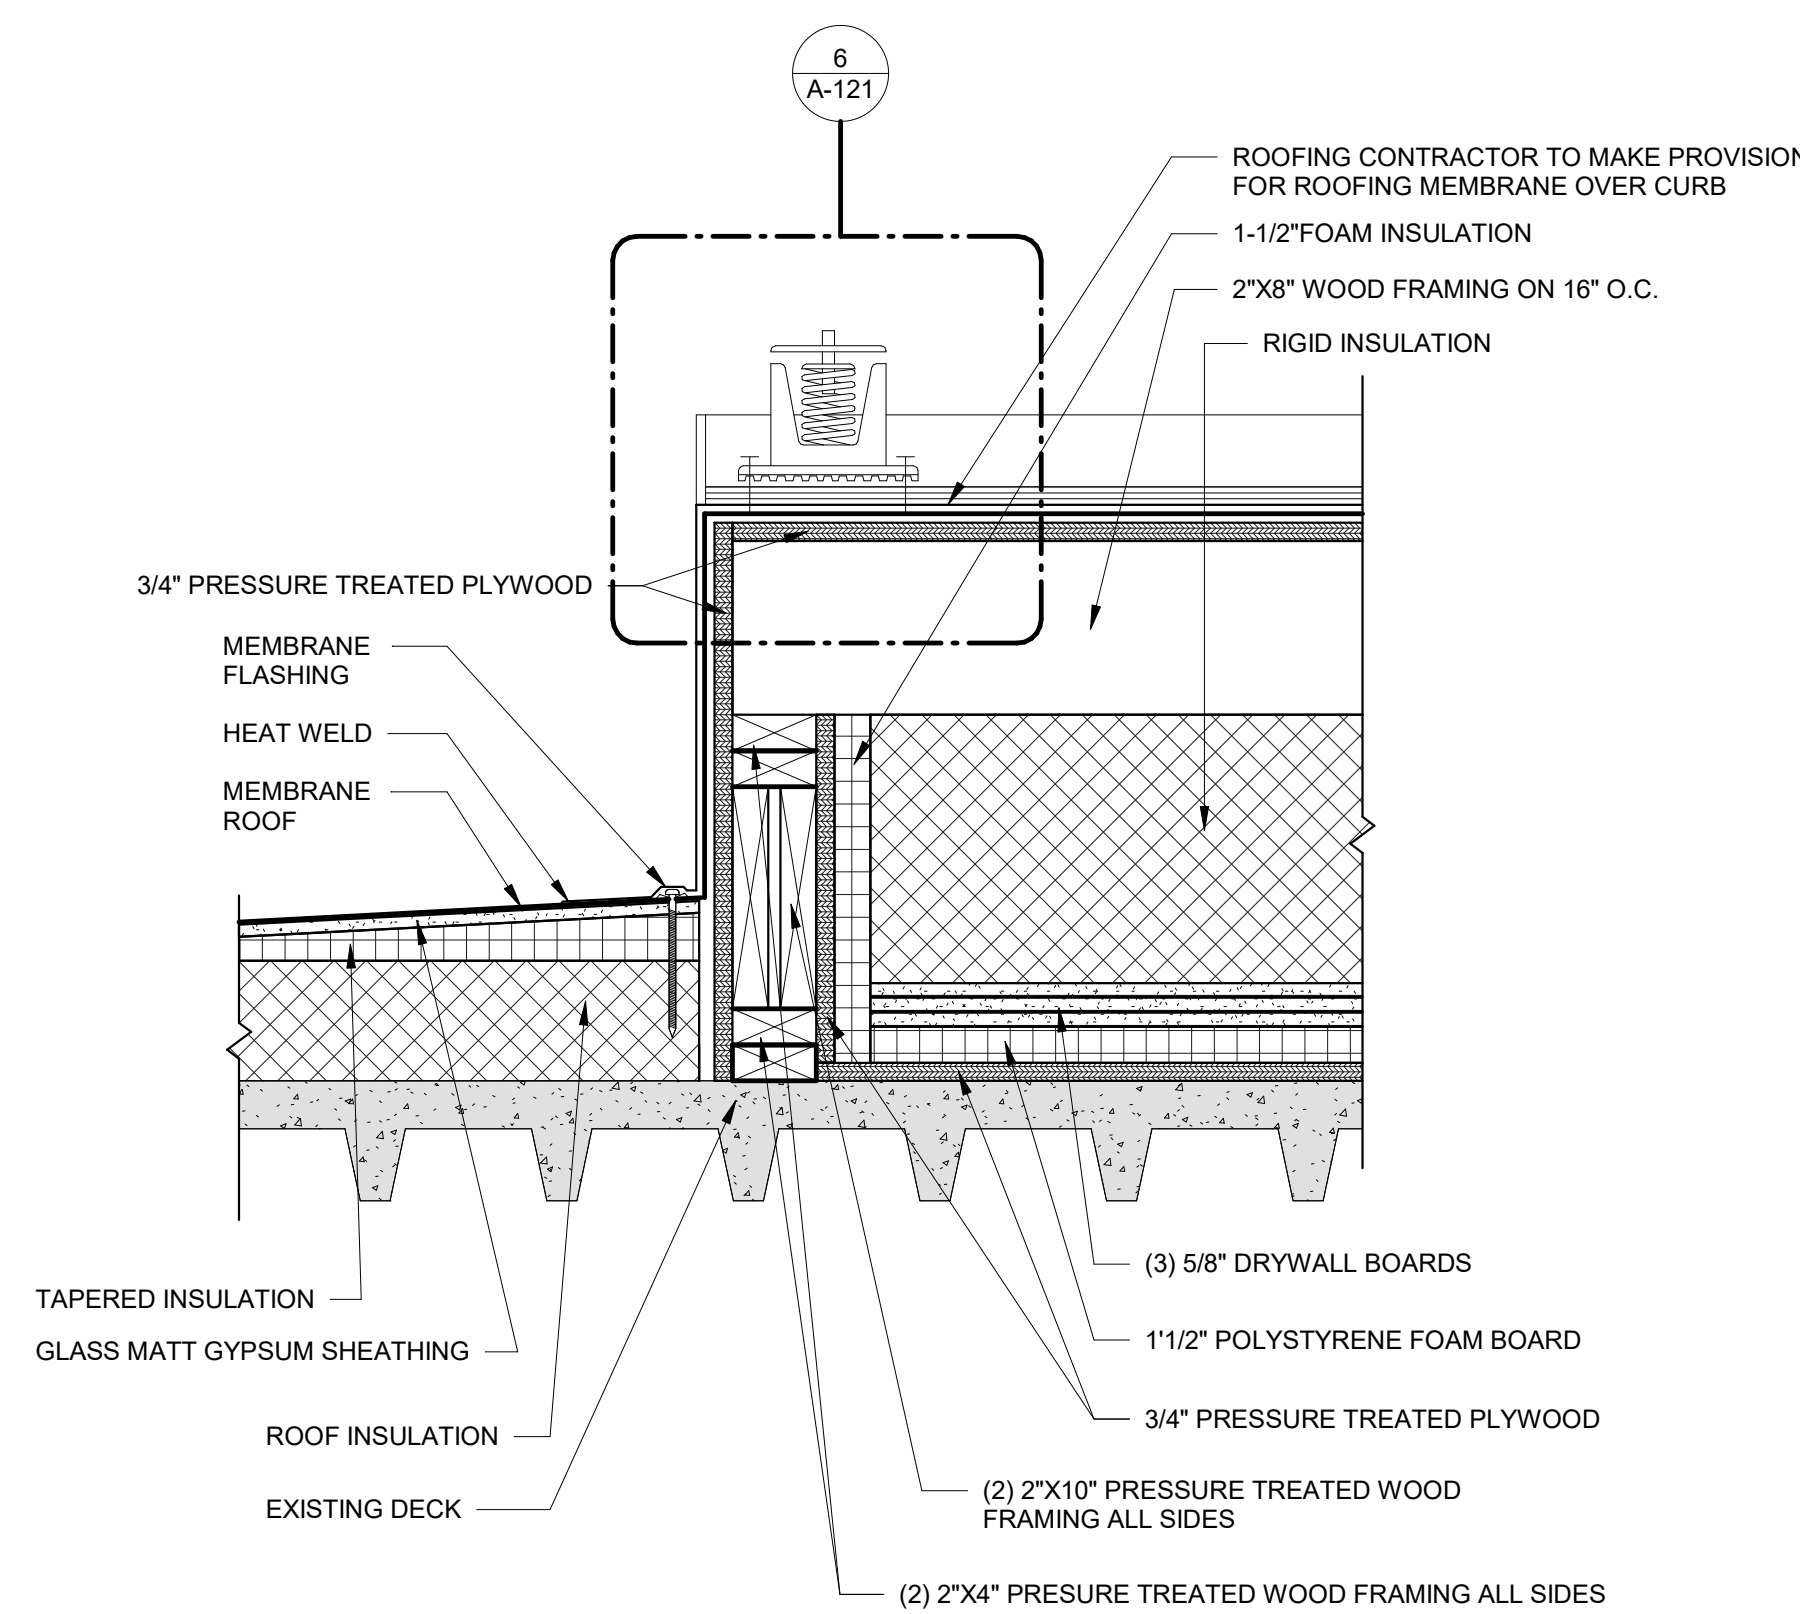


5 CHILLER CURB DETAIL
1 1/2" = 1'-0"

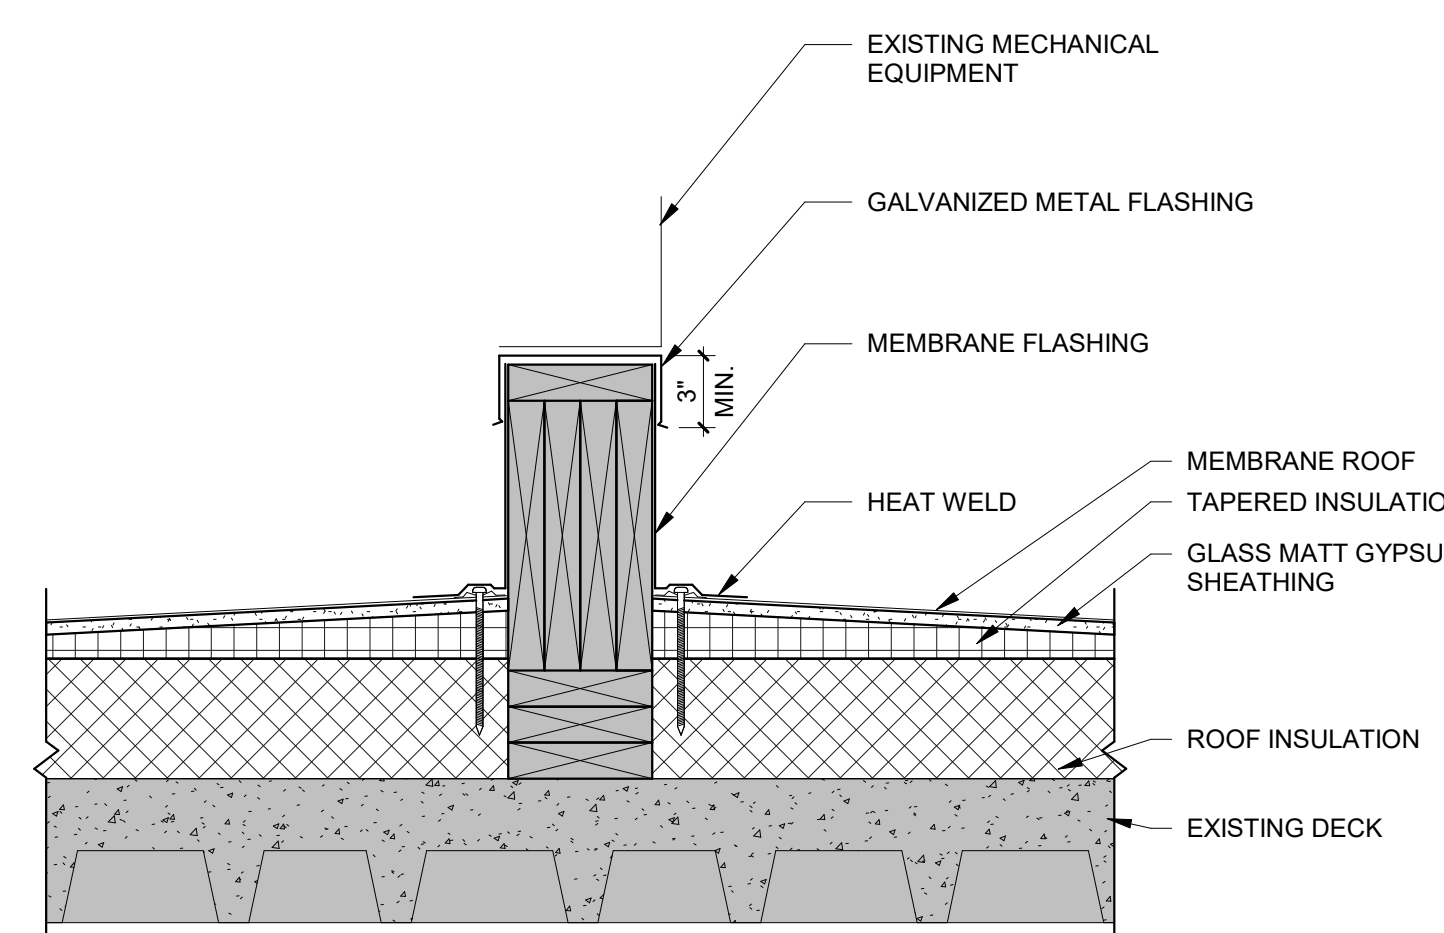


7 EXISTING ROOF CURB AT MECHANICAL UNIT
1 1/2" = 1'-0"

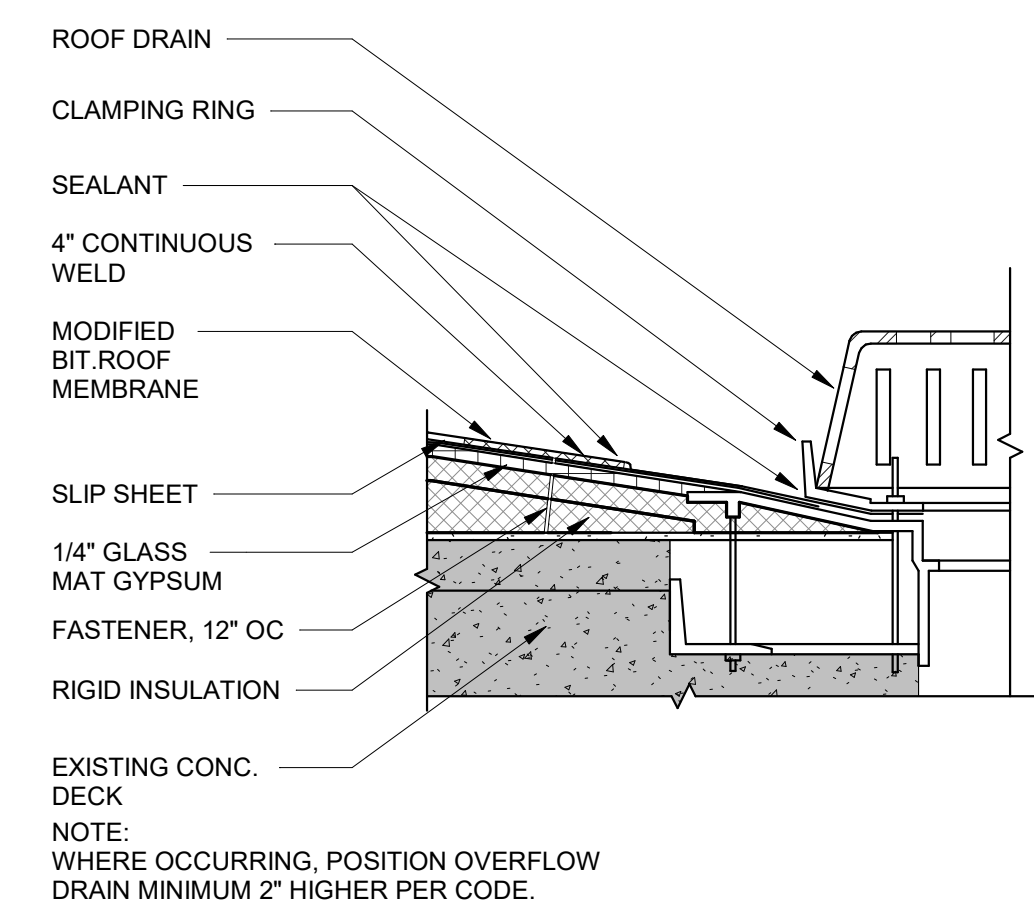

8 TYPICAL ROOF DRAIN DETAIL-CONC.
1 1/2" = 1'-0"

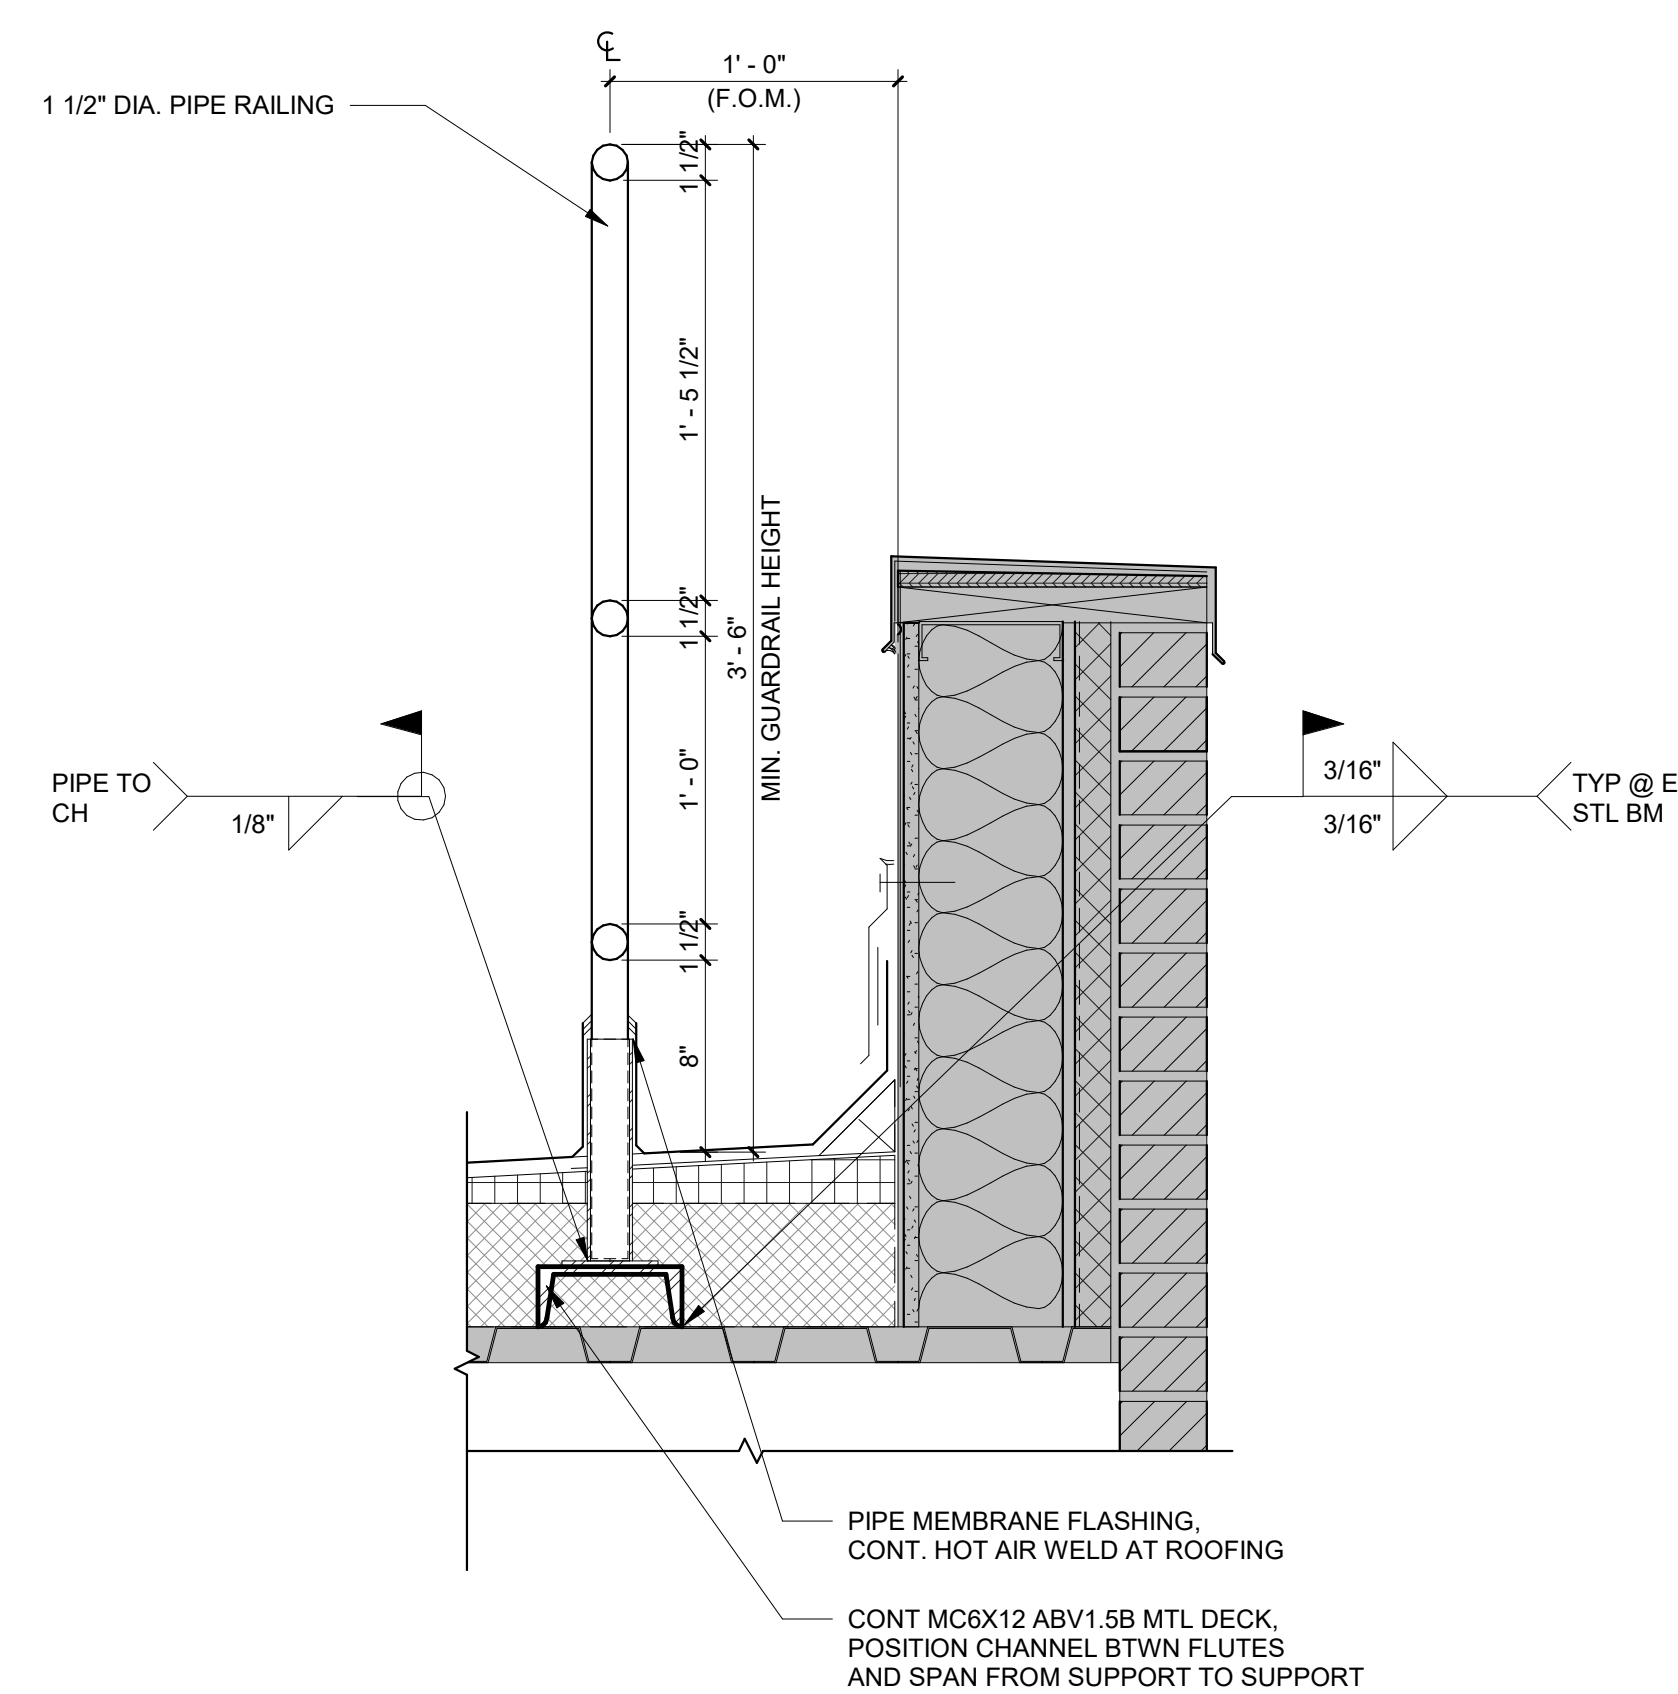

9 RAIL DETAIL
1 1/2" = 1'-0"

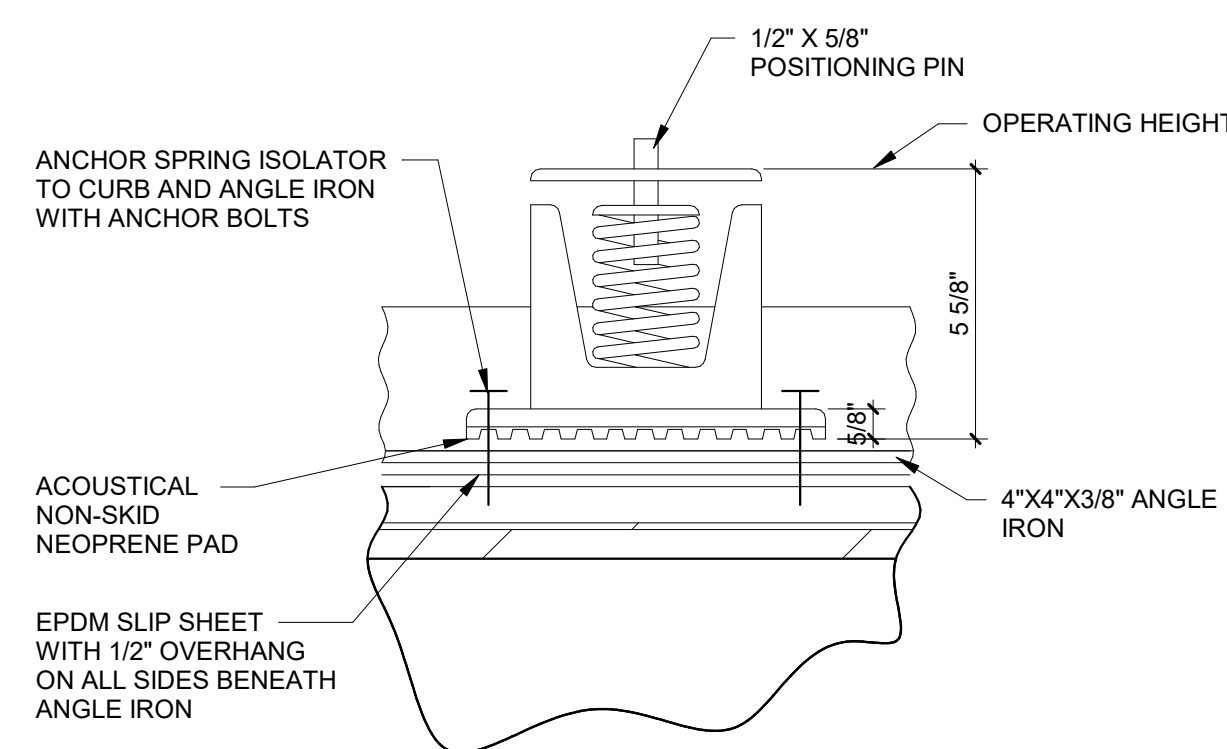


⑥ SPRING DETAIL
3" = 1'-0"

COMPLIANCE REVIEW COMPLETED	2/23/2024
Revisions:	Date

CONSULTANTS:



TERRASITE DESIGN
1635 DEADWOOD AVENUE
RAPID CITY, SOUTH DAKOTA 57702
PH: (605) 791-1736

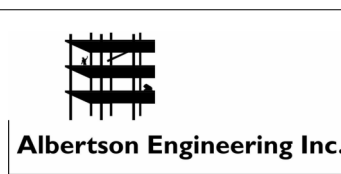

ALBERTSON ENGINEERING, INC.
315 NORTH MAIN AVENUE, SUITE 200
SIOUX FALLS, SOUTH DAKOTA 57104
PH: (605) 274-0880



FARRIS ENGINEERING
12700 WEST DODGE ROAD
OMAHA, NEBRASKA 68154
PH: (402) 330-5900



ARCHITECT



FOURFRONT DESIGN, INC.
517 7TH STREET
RAPID CITY, SOUTH DAKOTA 57701
PH: (605) 342-9470
FAX: (605) 342-2377
WWW.FOURFRONTDESIGN.COM


Drawing Title ROOF DETAILS Approved: Project Director Omaha VA Medical Center	Project Title Design/Construct Sterile Processing Service- Omaha VA Medical Center Location 4101 Woolworth Ave #4199 Omaha, Ne 68105 Date 11/23/2020 Checked JL Drawn GJC	Project Number 16.2330.A08 Building Number 25 Drawing Number A-121 Dwg. 39 of 143	Office of Construction and Facilities Management  Department of Veterans Affairs
--	--	---	--

GENERAL NOTES:


1. SHEET SIZE FOR PROPER SCALE IS 30x42. CONTRACTOR SHALL NOT SCALE DRAWINGS BUT SHALL REQUEST THE DESIRED DIMENSIONS FROM THE ARCHITECT.
2. SEE SHEET G-002 FOR GENERAL NOTES.
3. MAINTAIN FIRE WATCH WHEN DOUBLE EGRESS DOOR IS BLOCKED.

KEYNOTES:


- 04-20 COMMON BOND FACE BRICK TO MATCH EXISTING
04-22 VERTICAL CONTROL JOINT
05-01 METAL WALL PANEL, MATCH EXISTING, TYP.
07-60 PREFINISHED METAL COPING, SEE SCHEDULE FOR FINISH
23-40 MECHANICAL LOUVER, SEE MECHANICAL DRAWINGS
23-41 MECHANICAL EQUIPMENT, SEE MECHANICAL DRAWINGS

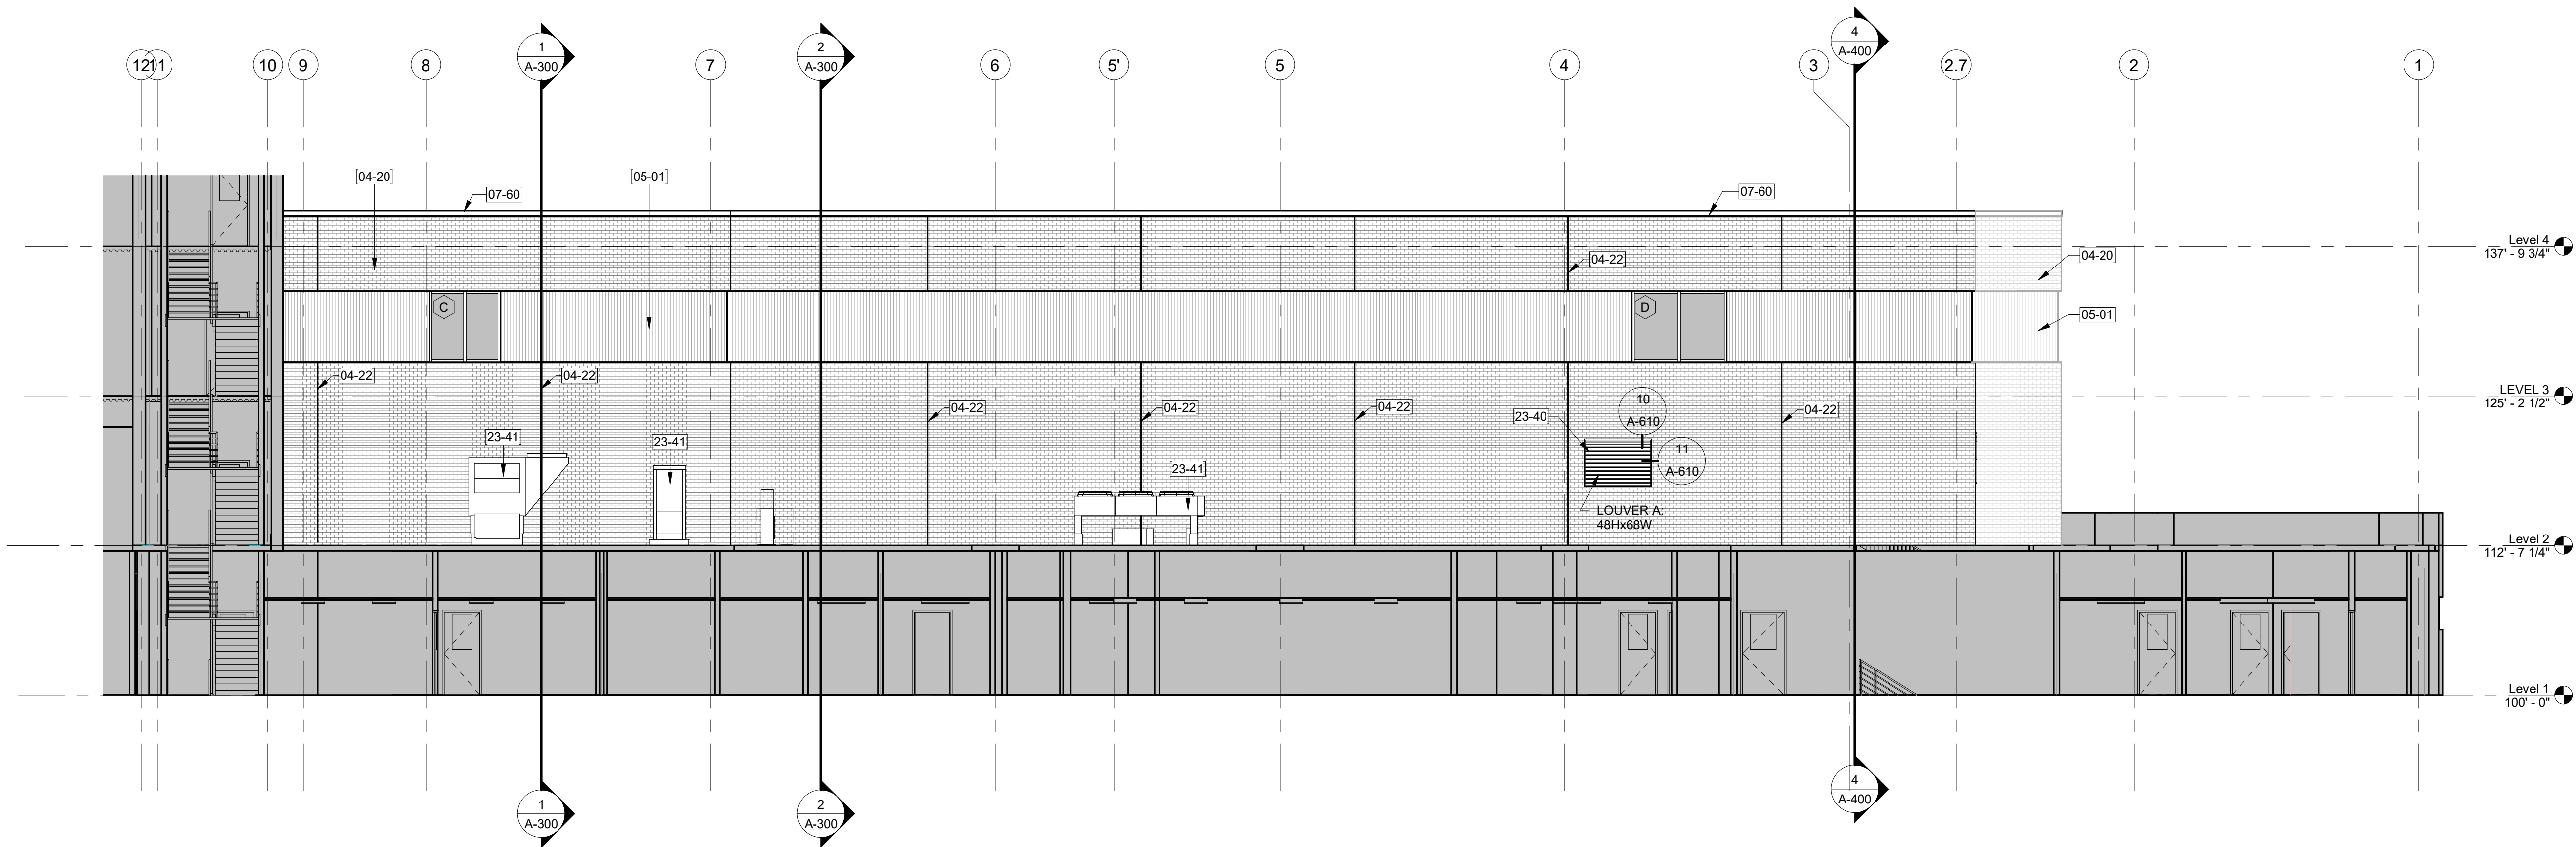

1 EAST EXTERIOR ELEVATION
1/8" = 1'-0"

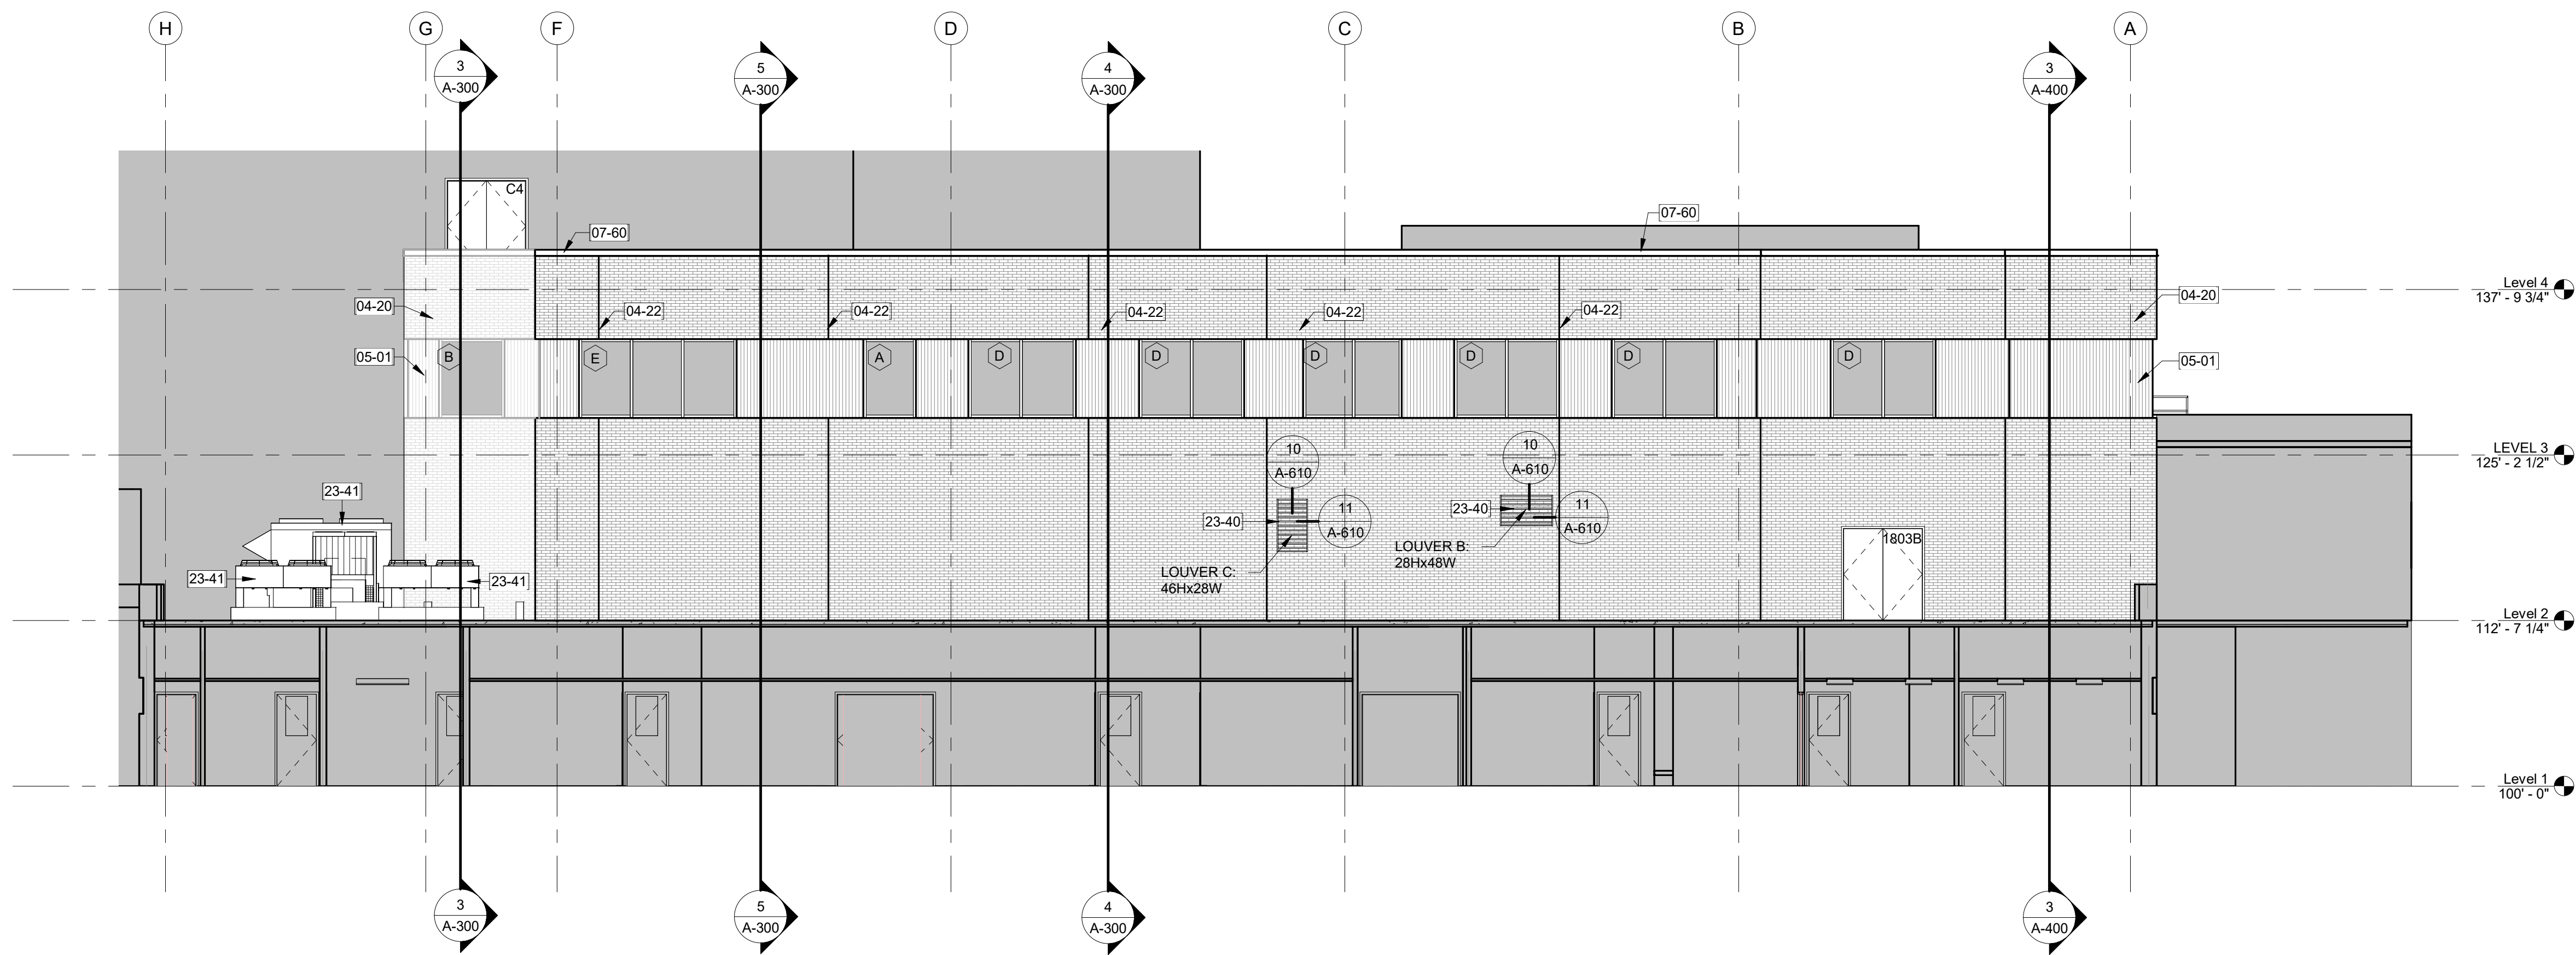

2 NORTH EXTERIOR ELEVATION
1/8" = 1'-0"

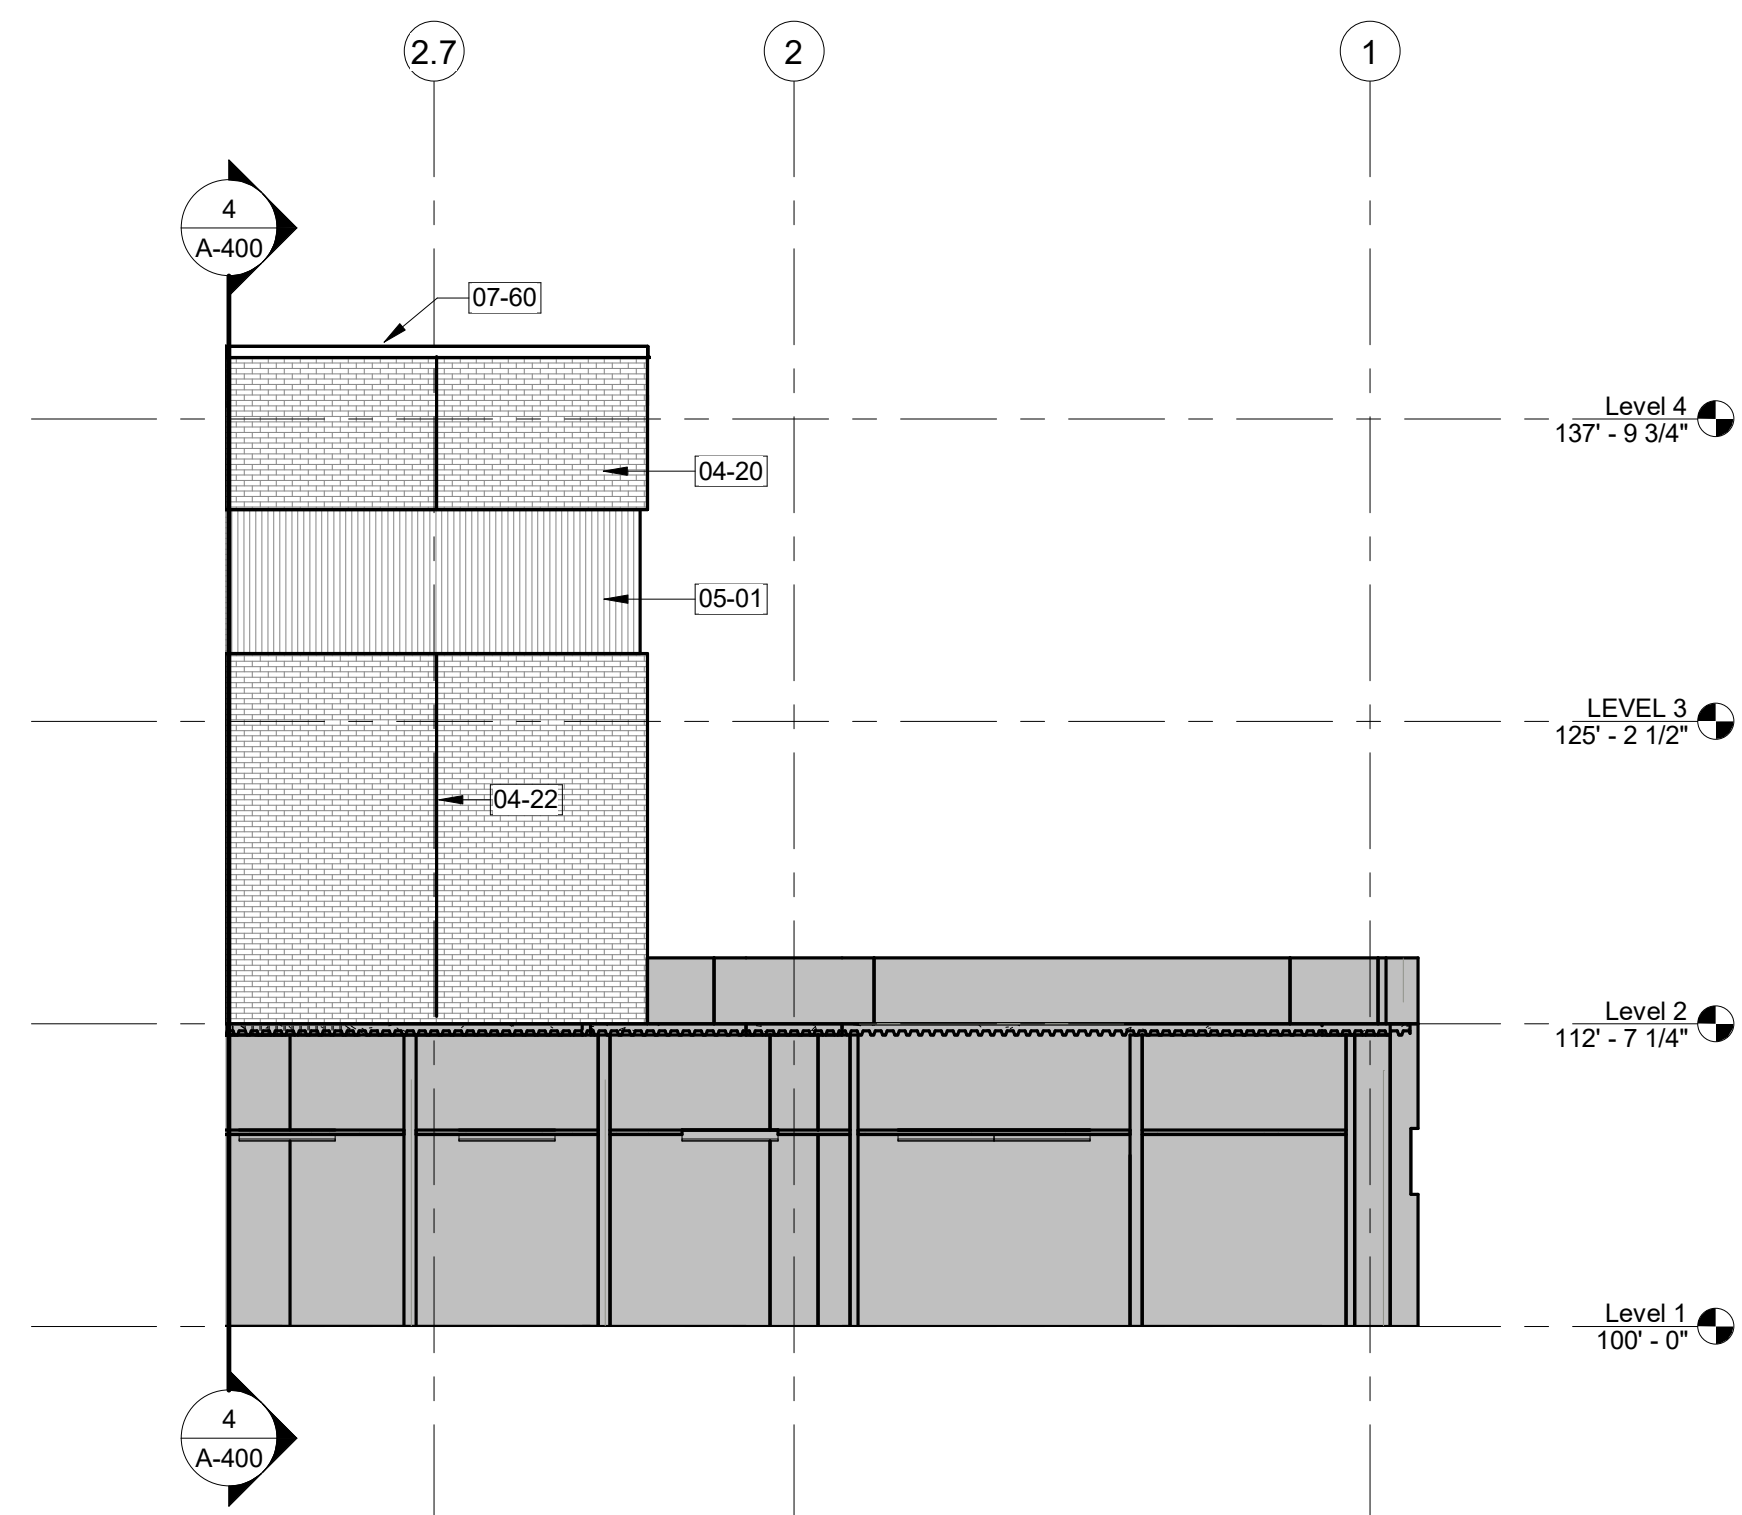

3 EAST STAIR TOWER EXTERIOR ELEVATION
1/8" = 1'-0"

CONSTRUCTION DOCUMENTS


COMPLIANCY REVIEW COMPLETED Revisions:		CONSULTANTS: TERRASITE DESIGN 1635 DEADWOOD AVENUE RAPID CITY, SOUTH DAKOTA 57702 PH: (605) 791-1736 Albertson Engineering Inc. FARRIS ENGINEERING OMAHA (BRICK) BENTLEY COUNCIL BLUFFS PH: (402) 330-5900 ALBERTSON ENGINEERING, INC. 315 NORTH MAIN AVENUE, SUITE 200 SIOUX FALLS, SOUTH DAKOTA 57104 PH: (605) 274-0880 FARRIS ENGINEERING 12700 WEST DODGE ROAD OMAHA, NEBRASKA 68154 PH: (402) 330-5900		ARCHITECT FOURFRONT DESIGN, INC. 517 7TH STREET RAPID CITY, SOUTH DAKOTA 57701 PH: (605) 342-9470 FAX: (605) 342-2377 WWW.FOURFRONTDESIGN.COM	Drawing Title EXTERIOR ELEVATIONS Approved: Project Director Omaha VA Medical Center	Project Title Design/Construct Sterile Processing Service- Omaha VA Medical Center Location 4101 Woolworth Ave #4199 Omaha, Ne 68105 Date 11/23/2020 Checked JL Drawn JGC	Project Number 16.2330.A08 Building Number 25 Drawing Number A-200 Dwg. 40 of 143	Office of Construction and Facilities Management Department of Veterans Affairs
--	--	---	--	--	--	---	--	---

GENERAL NOTES:

1. SHEET SIZE FOR PROPER SCALE IS 30X42. CONTRACTOR SHALL NOT SCALE DRAWINGS BUT SHALL REQUEST THE DESIRED DIMENSIONS FROM THE ARCHITECT.
2. SEE SHEET G-002 FOR GENERAL NOTES.
3. MAINTAIN FIRE WATCH WHEN DOUBLE EGRESS DOOR IS BLOCKED.


KEYNOTES:

- 04-20 COMMON BOND FACE BRICK TO MATCH EXISTING
- 04-22 VERTICAL CONTROL JOINT
- 05-01 METAL WALL PANEL, MATCH EXISTING. TYP.
- 07-60 PREFINISHED METAL COPING, SEE SCHEDULE FOR FINISH
- 10-56 FALL PROTECTION RAILING, TYP.
- 23-41 MECHANICAL EQUIPMENT, SEE MECHANICAL DRAWINGS.

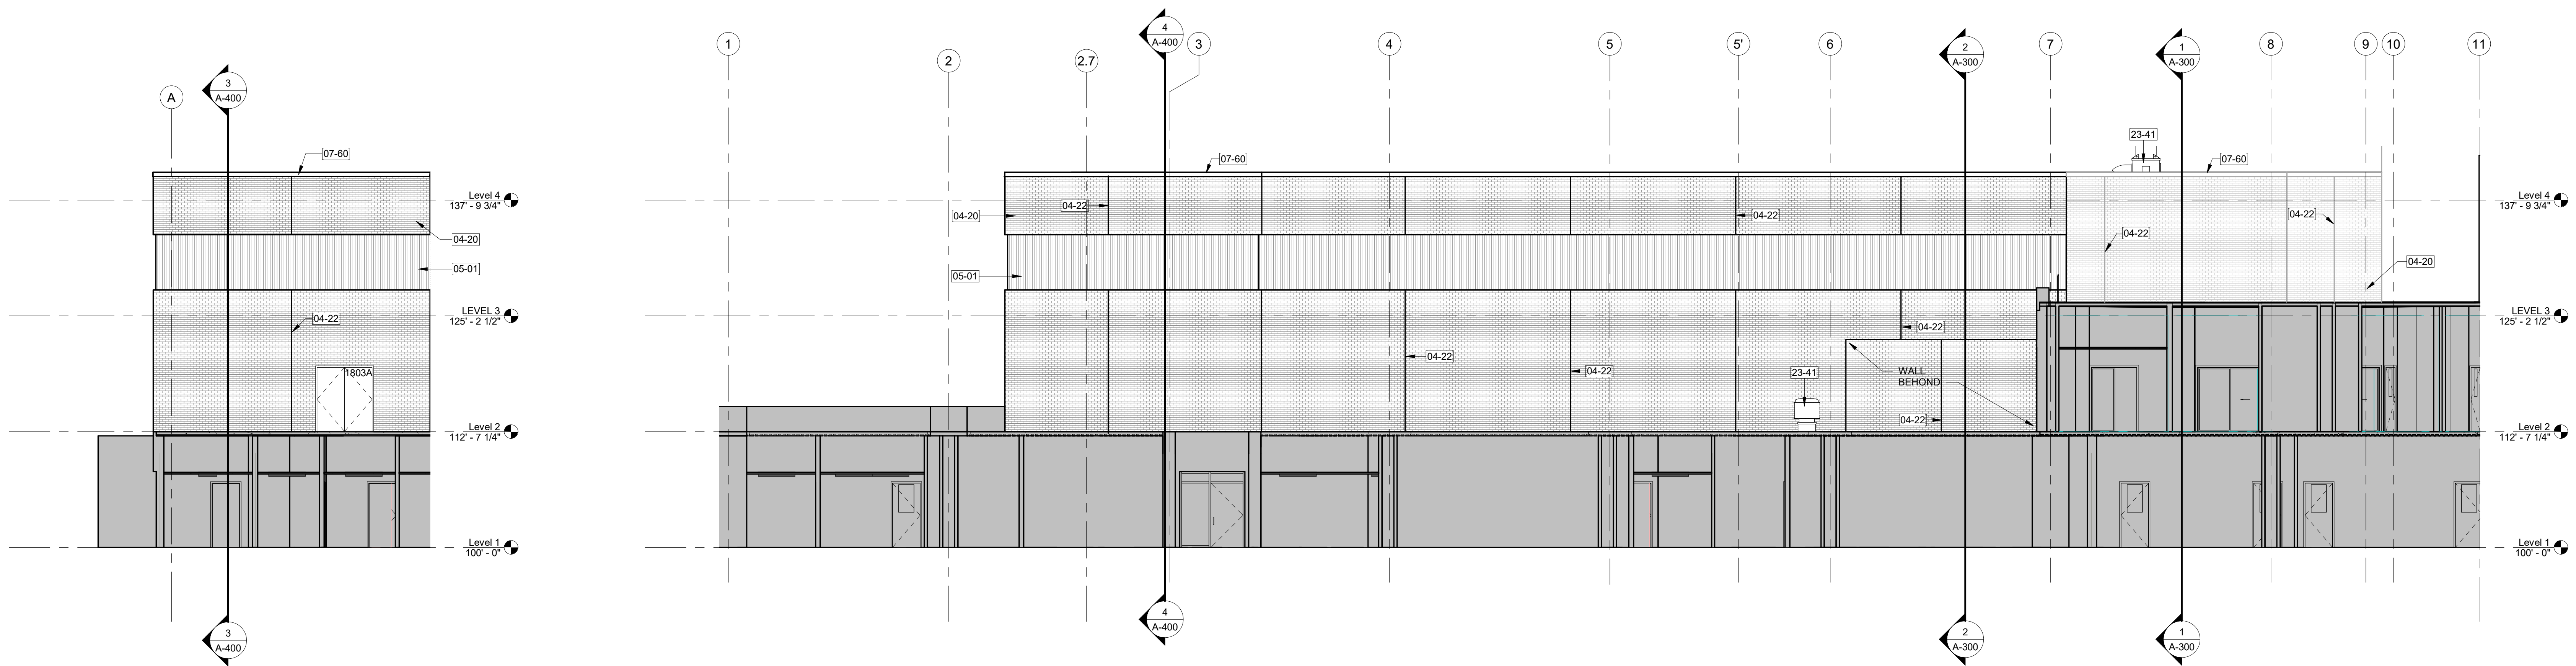

2 SOUTH STAIR TOWER EXTERIOR ELEVATION
1/8" = 1'-0"

3 WEST EXTERIOR ELEVATION
1/8" = 1'-0"

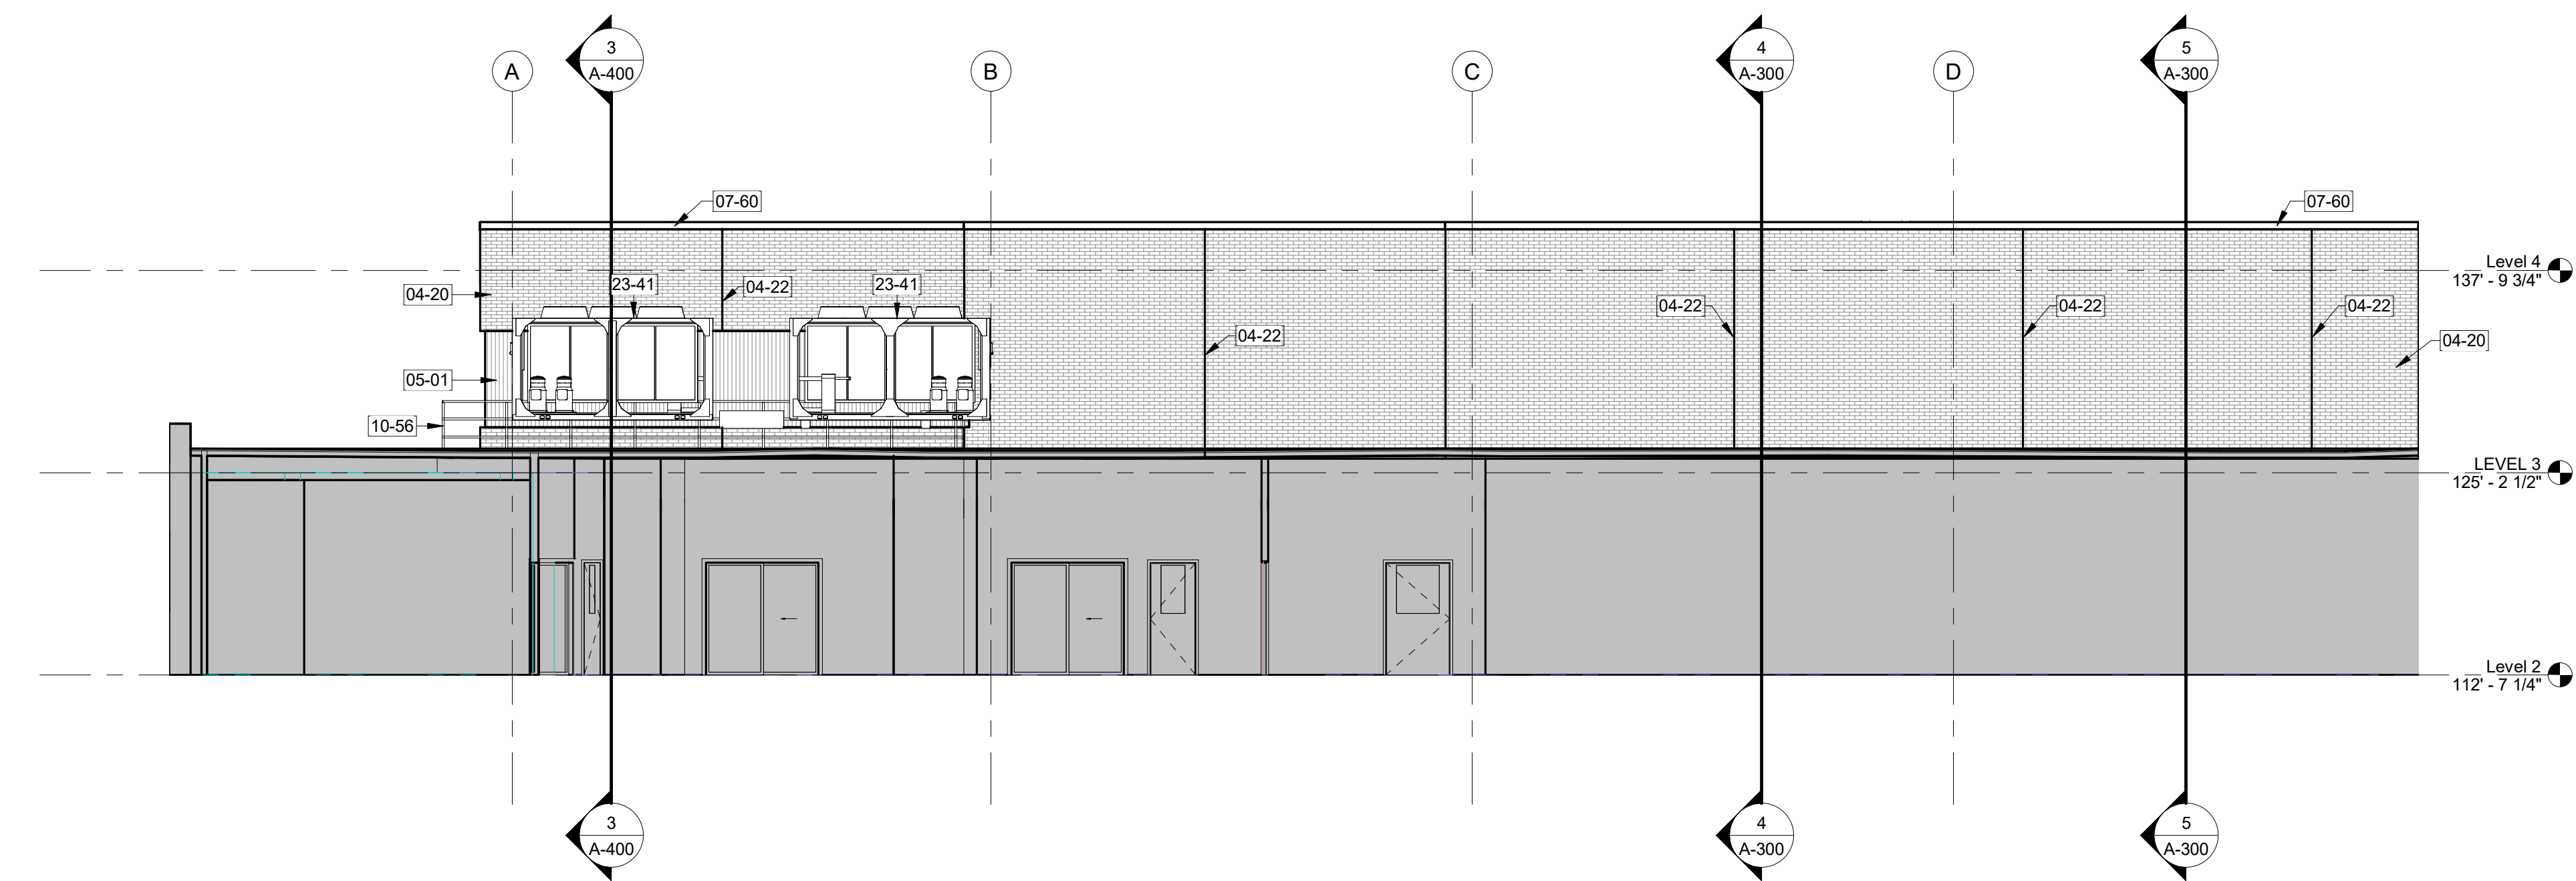


1 SOUTH EXTERIOR ELEVATION
1/8" = 1'-0"

CONSTRUCTION DOCUMENTS


6/1/2025 5:11:57 PM COMPLIANCY REVIEW COMPLETED Revisions:		CONSULTANTS: TERRASITE DESIGN 1635 DEADWOOD AVENUE RAPID CITY, SOUTH DAKOTA 57702 PH: (605) 791-1736 Albertson Engineering Inc. 315 NORTH MAIN AVENUE, SUITE 200 SIoux FALLS, SOUTH DAKOTA 57104 PH: (605) 274-0880 FARRIS ENGINEERING OMAHA [BRANCH] 12700 WEST DODGE ROAD OMAHA, NEBRASKA 68154 PH: (402) 330-5900		ARCHITECT FOURFRONT DESIGN, INC. 517 7TH STREET RAPID CITY, SOUTH DAKOTA 57701 PH: (605) 342-9470 FAX: (605) 342-2377 WWW.FOURFRONTDESIGN.COM REGISTERED PROFESSIONAL ARCHITECT 12837 LOG P 11-23-25		Drawing Title EXTERIOR ELEVATIONS Approved: Project Director Omaha VA Medical Center		Project Title Design/Construct Sterile Processing Service- Omaha VA Medical Center Location 4101 Woolworth Ave #4199 Omaha, Ne 68105 Date 11/23/2020 Checked JL Drawn JGC		Project Number 16.2330.A08 Building Number 25 Drawing Number A-201 Dwg. 41 of 143		Office of Construction and Facilities Management Department of Veterans Affairs	
---	--	---	--	---	--	--	--	---	--	--	--	---	--

GENERAL NOTES:


1. SHEET SIZE FOR PROPER SCALE IS 30X42. CONTRACTOR SHALL NOT SCALE DRAWINGS BUT SHALL REQUEST THE DESIRED DIMENSIONS FROM THE ARCHITECT.
2. SEE SHEET G-002 FOR GENERAL NOTES.
3. MAINTAIN FIRE WATCH WHEN DOUBLE EGRESS DOOR IS BLOCKED.

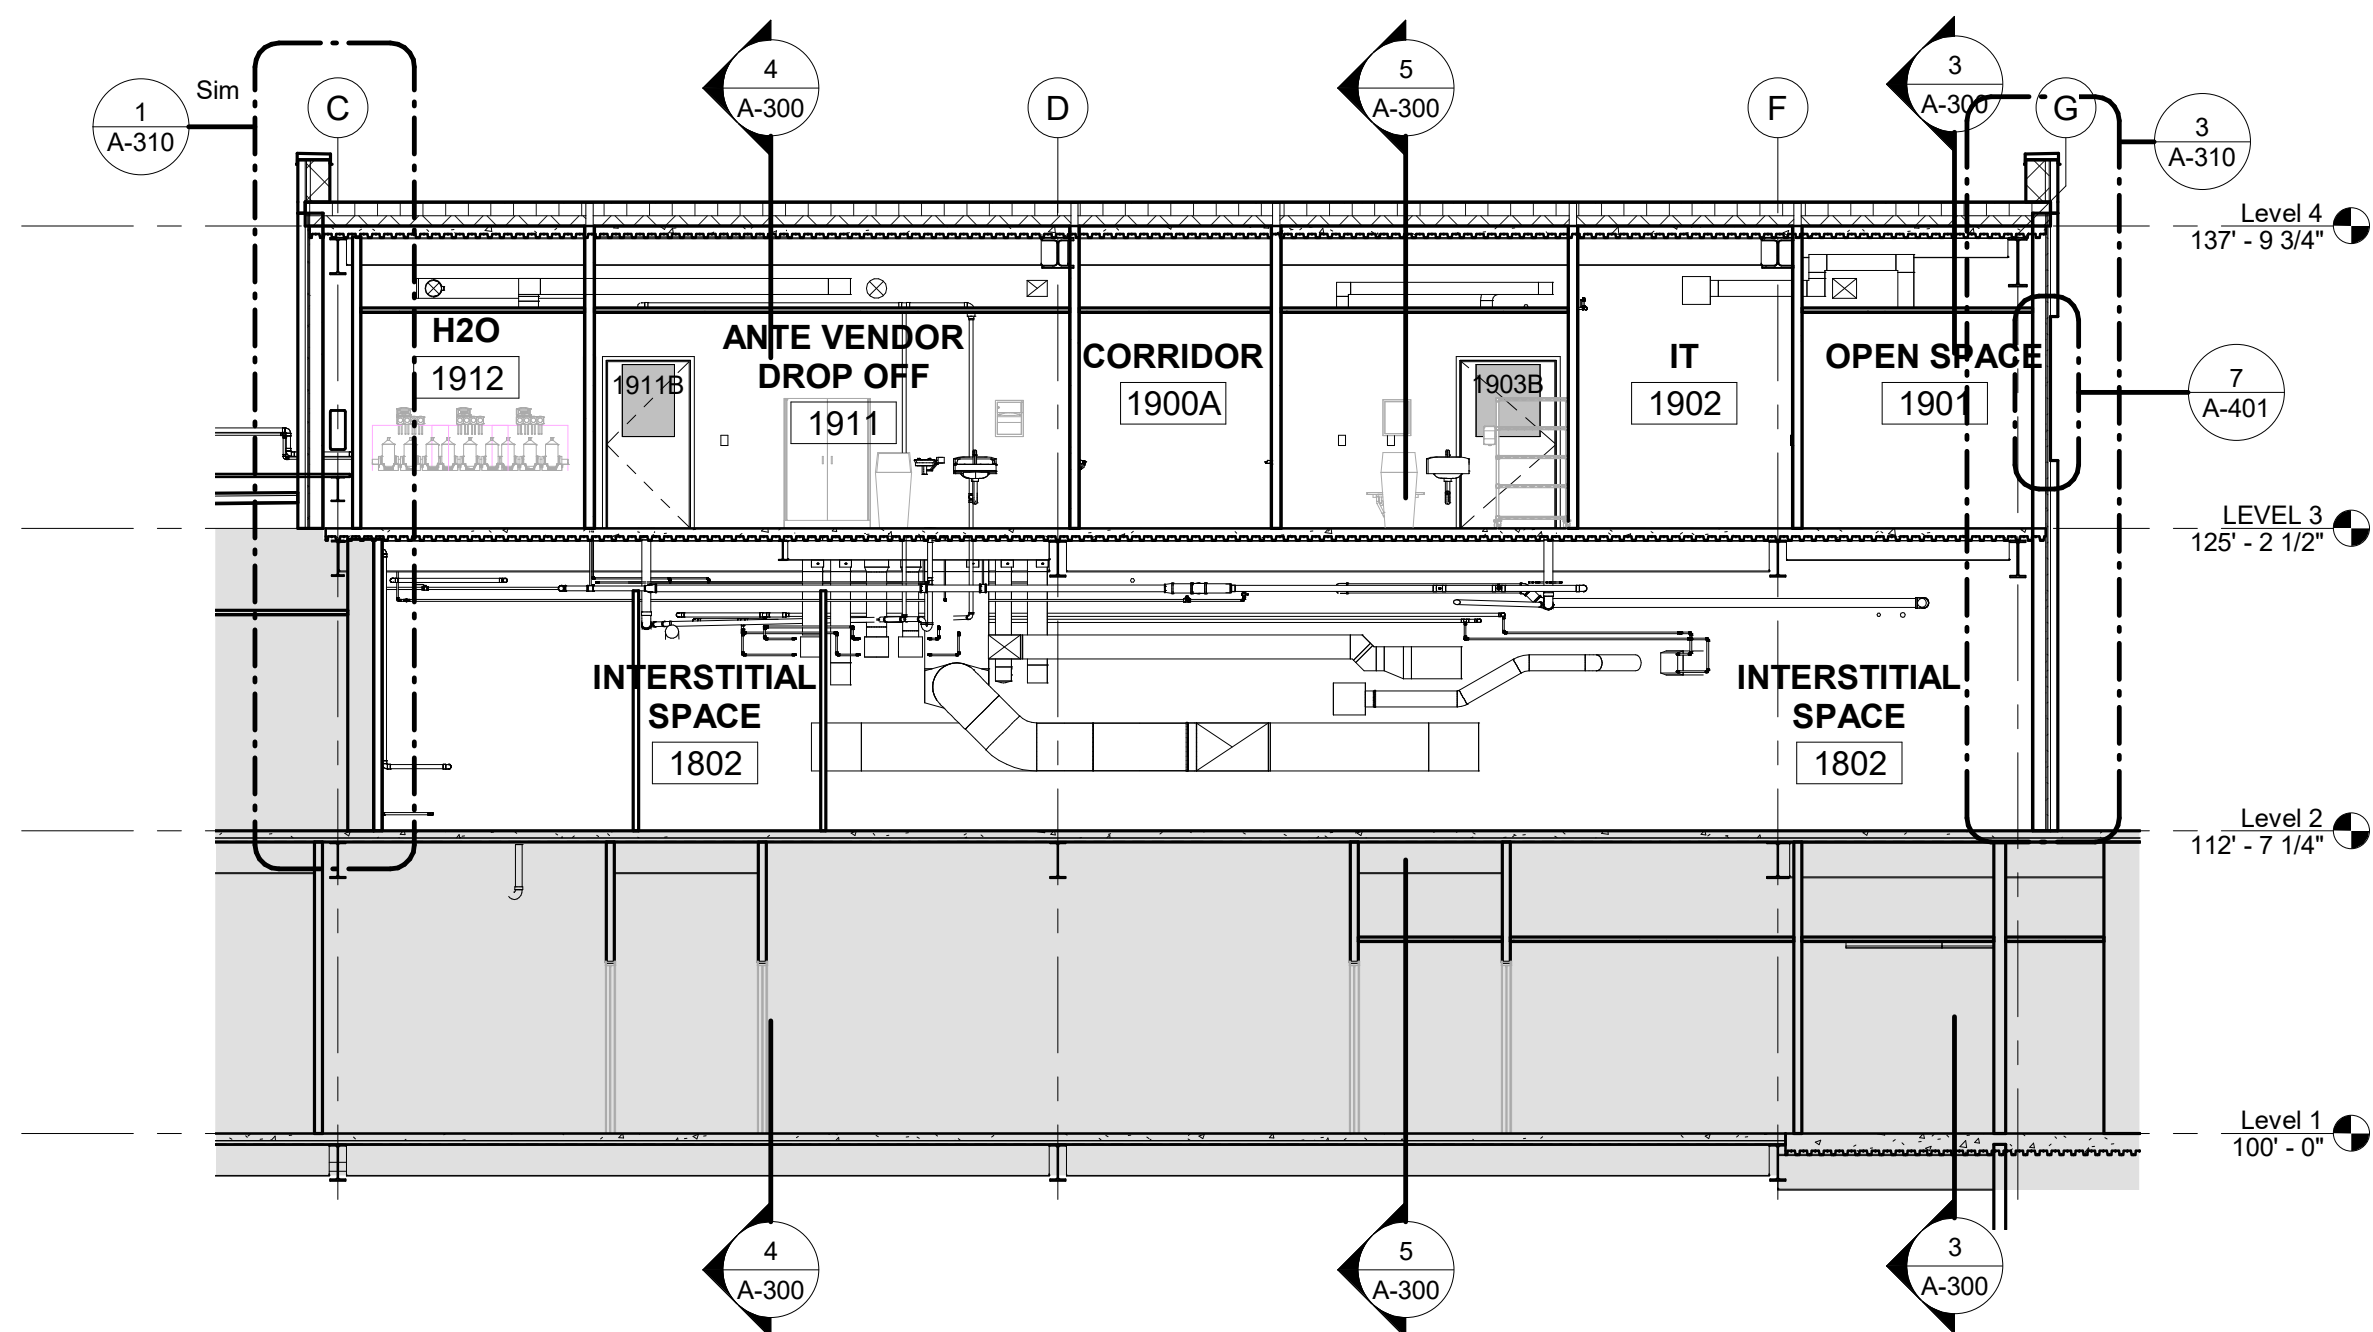


1 BUILDING SECTION
1/8" = 1'-0"

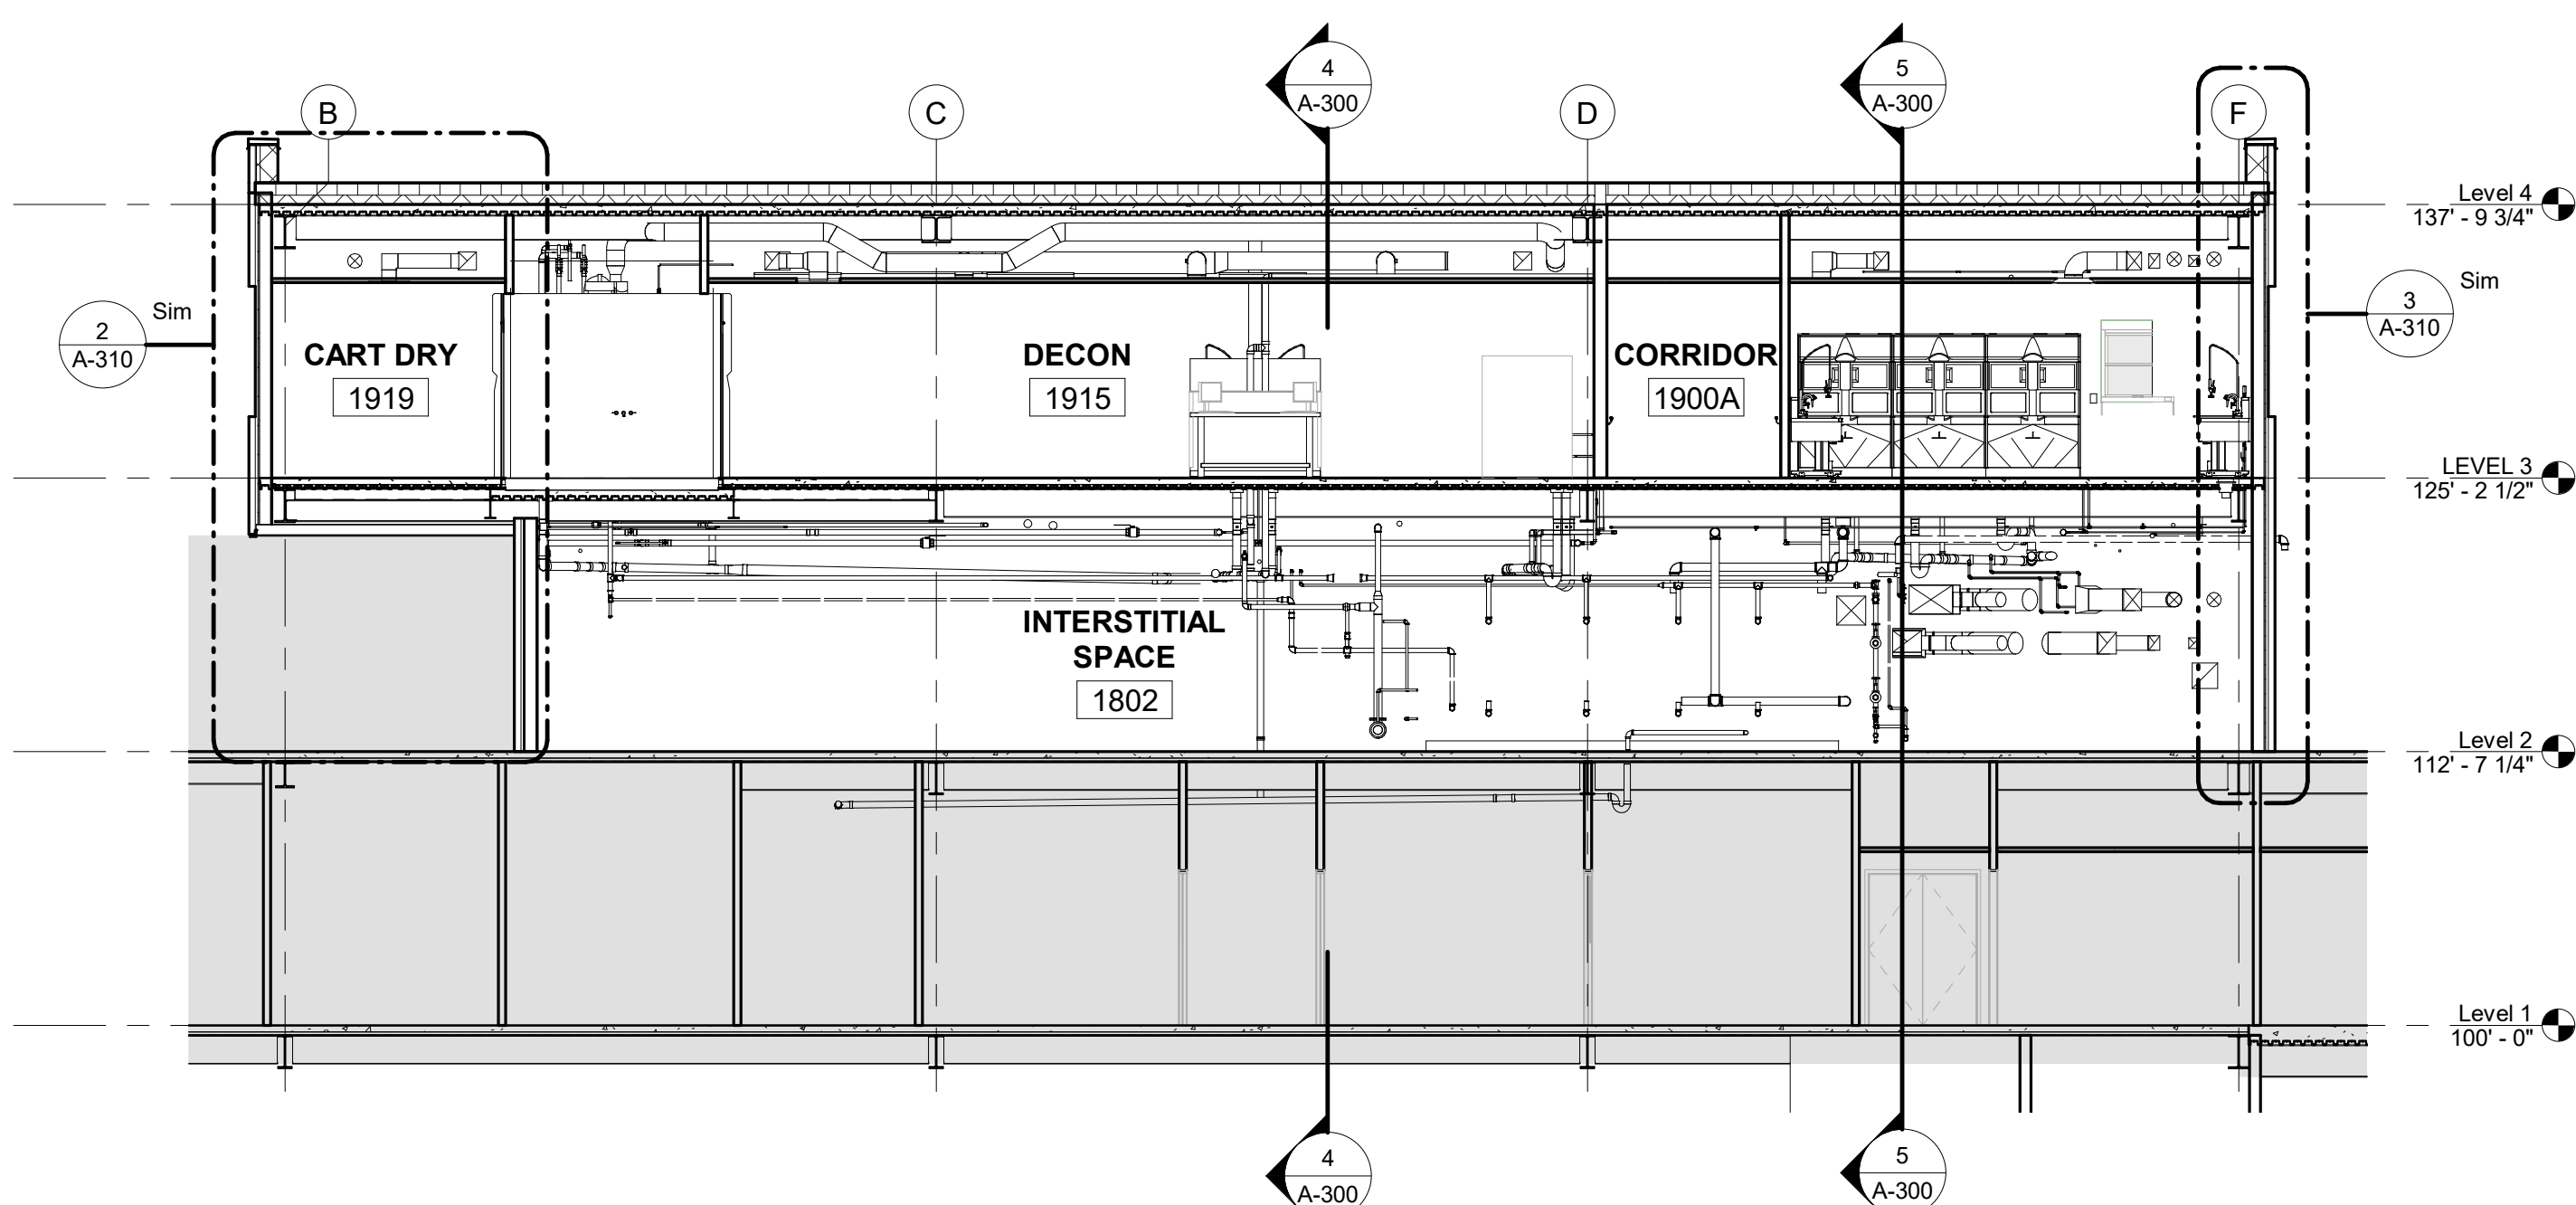


2 BUILDING SECTION
1/8" = 1'-0"

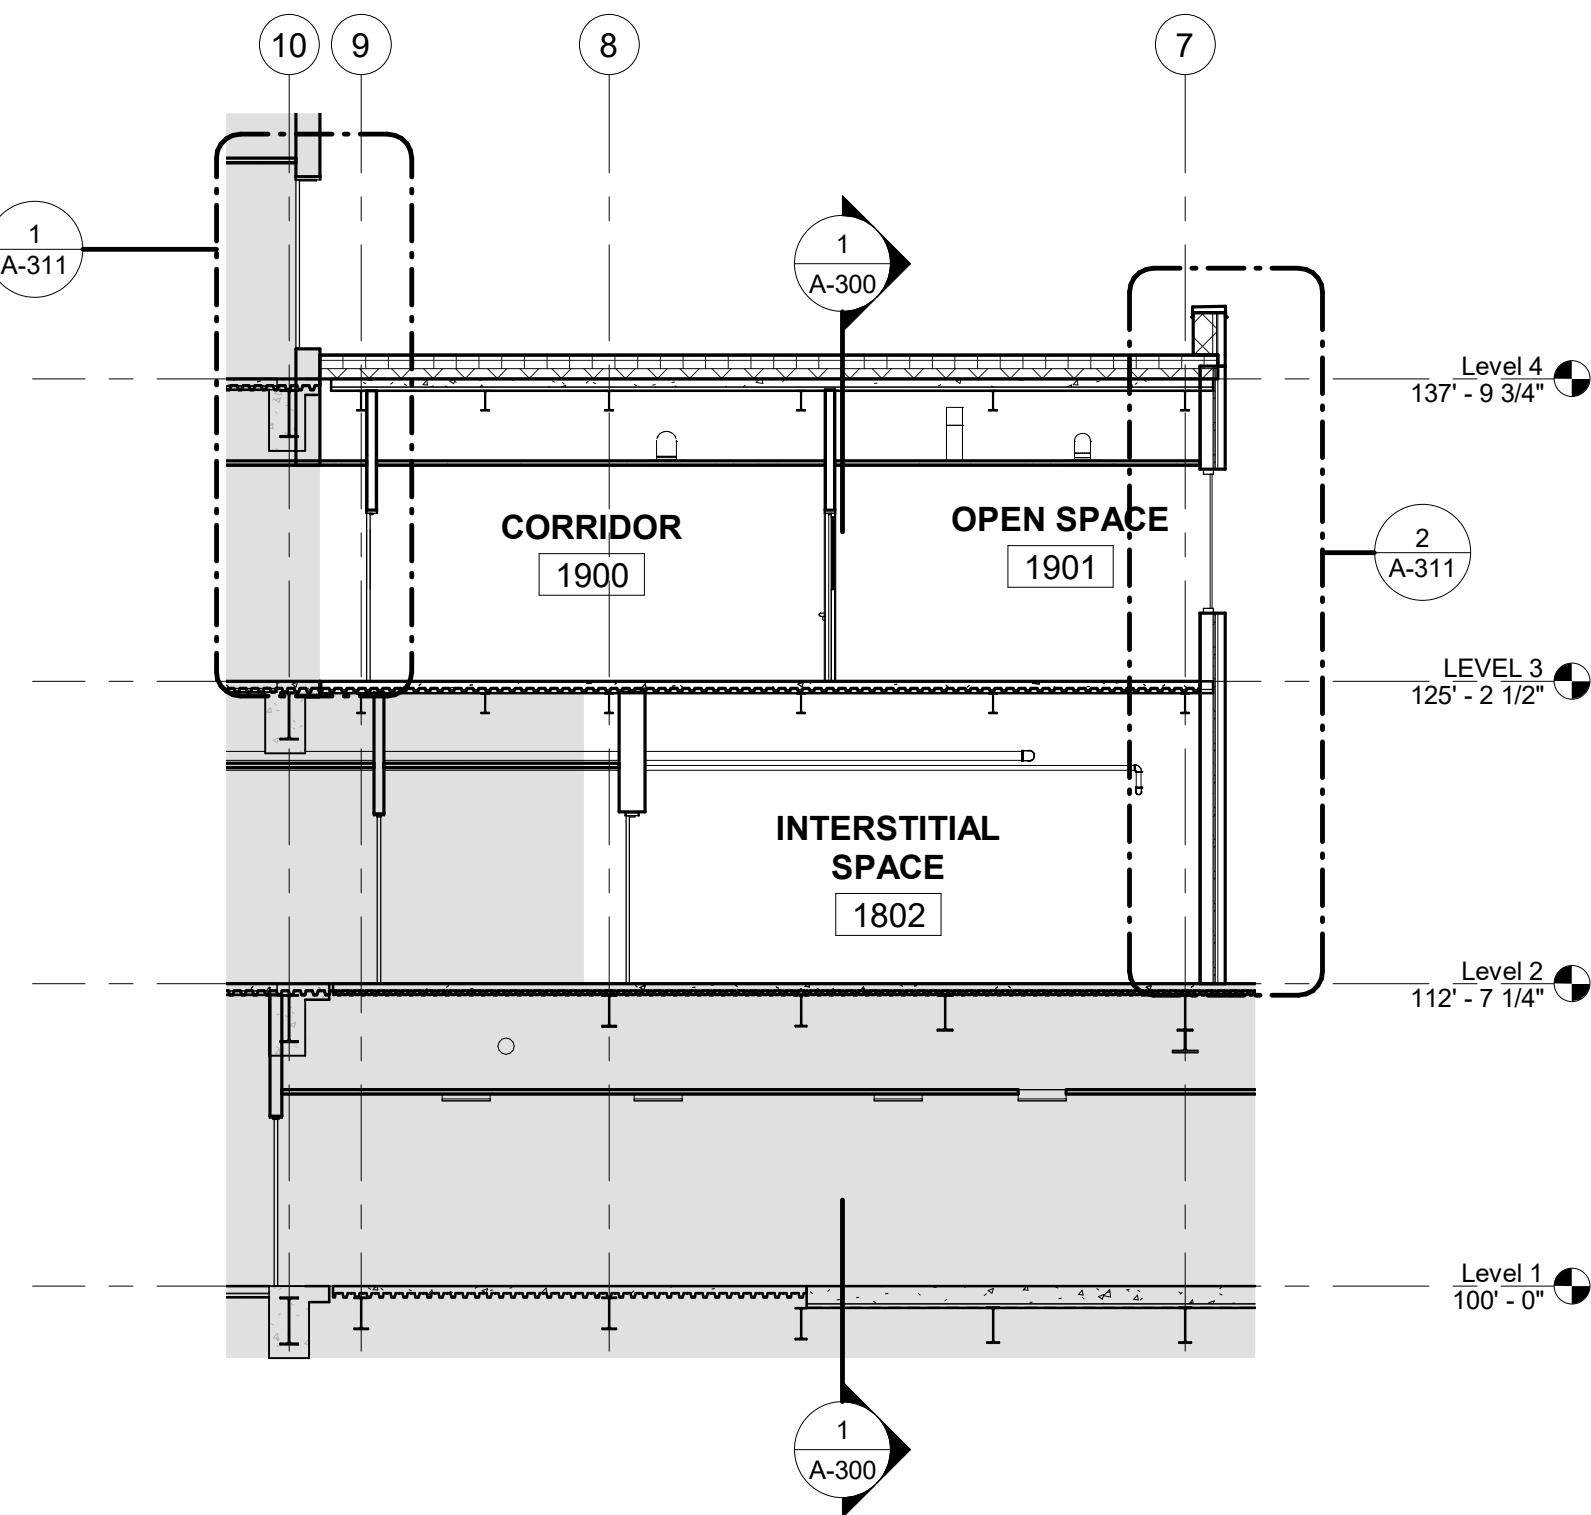

3 BUILDING SECTION
1/8" = 1'-0"

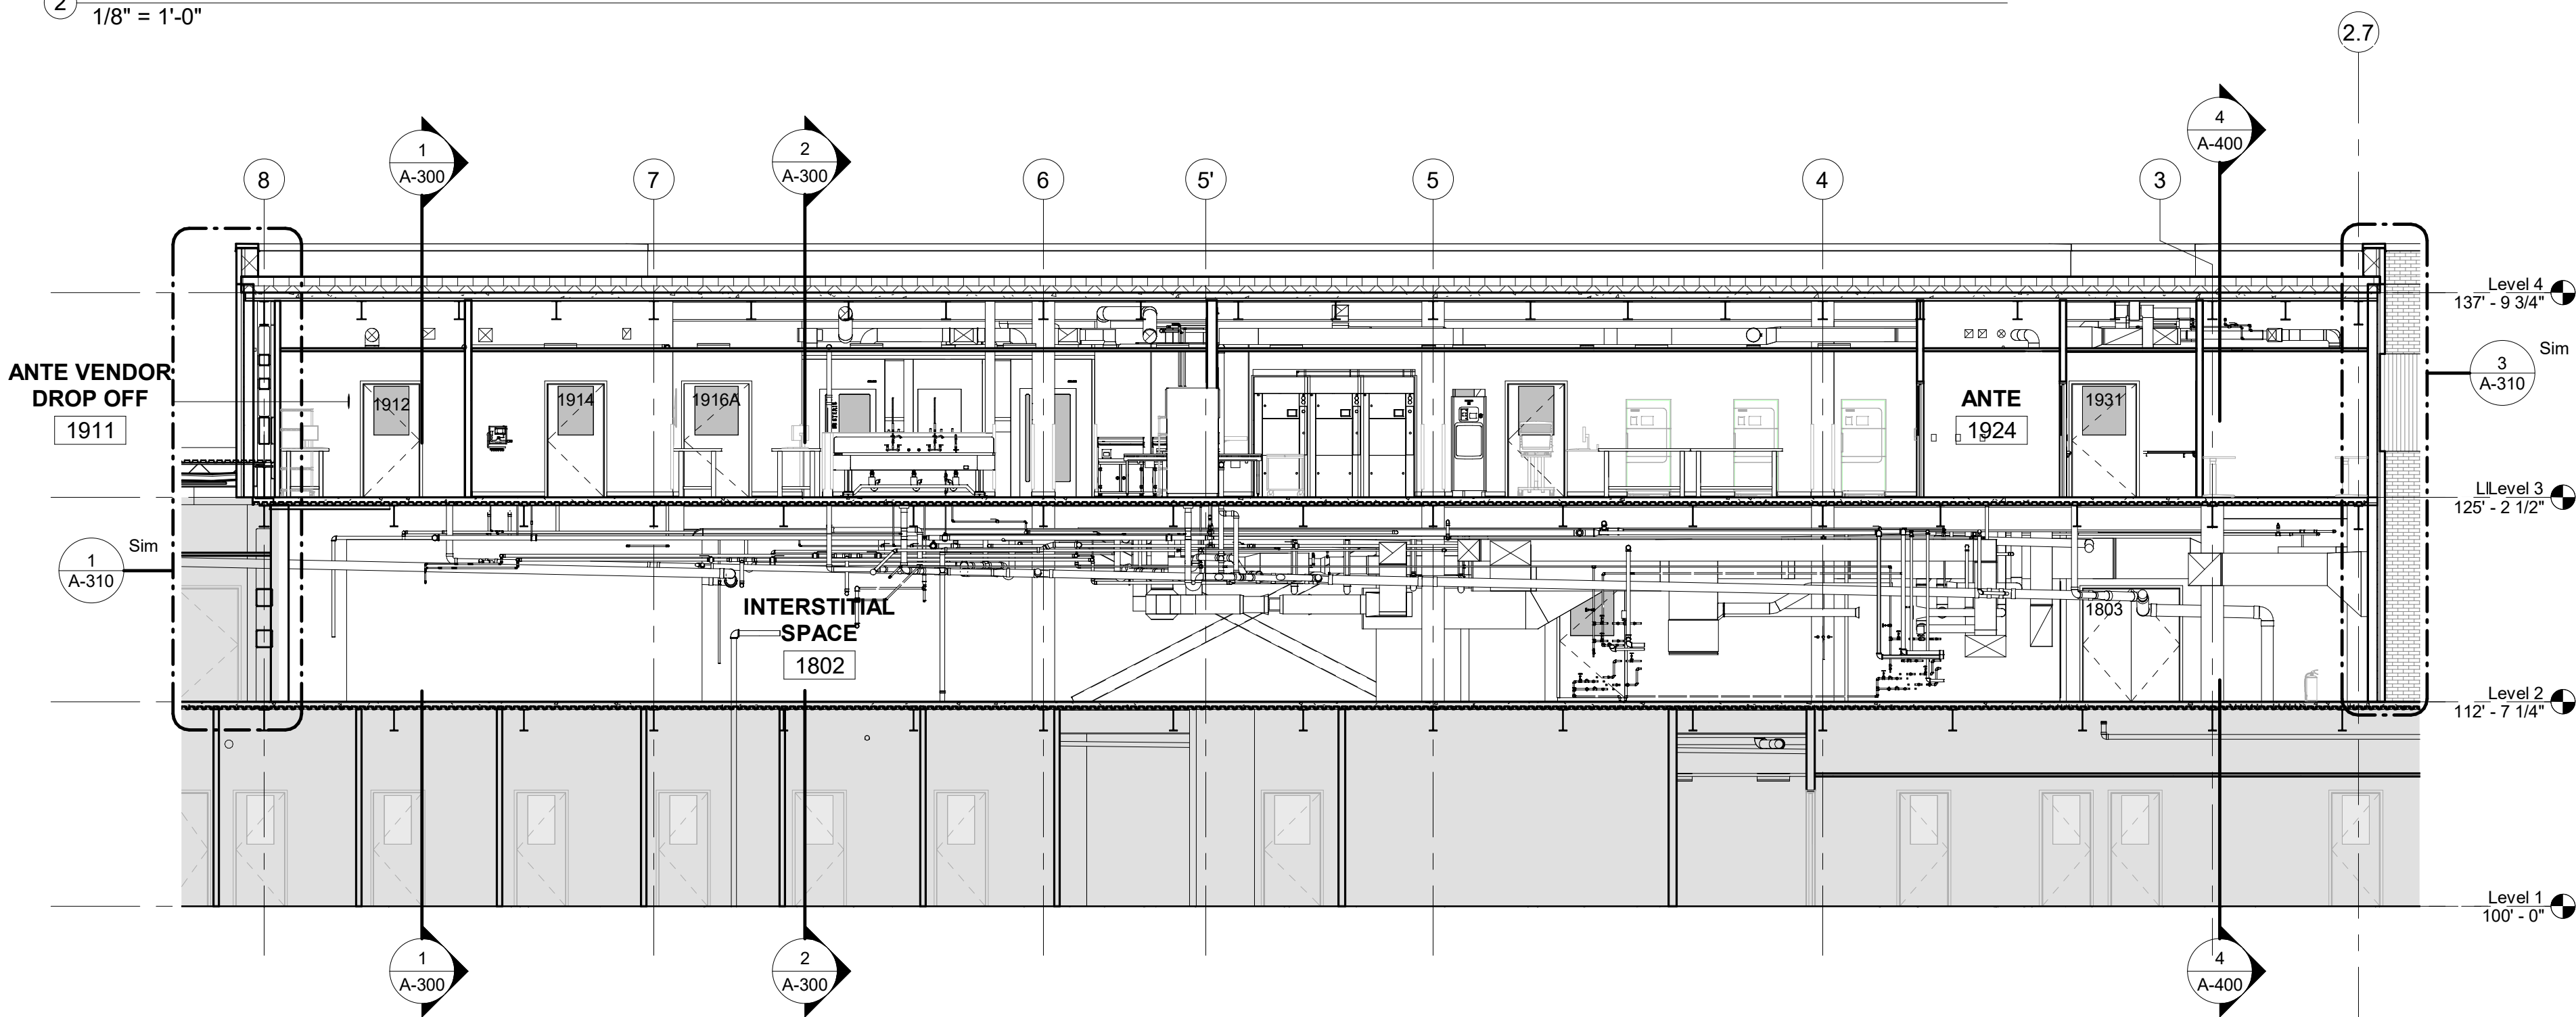

4 BUILDING SECTION
1/8" = 1'-0"

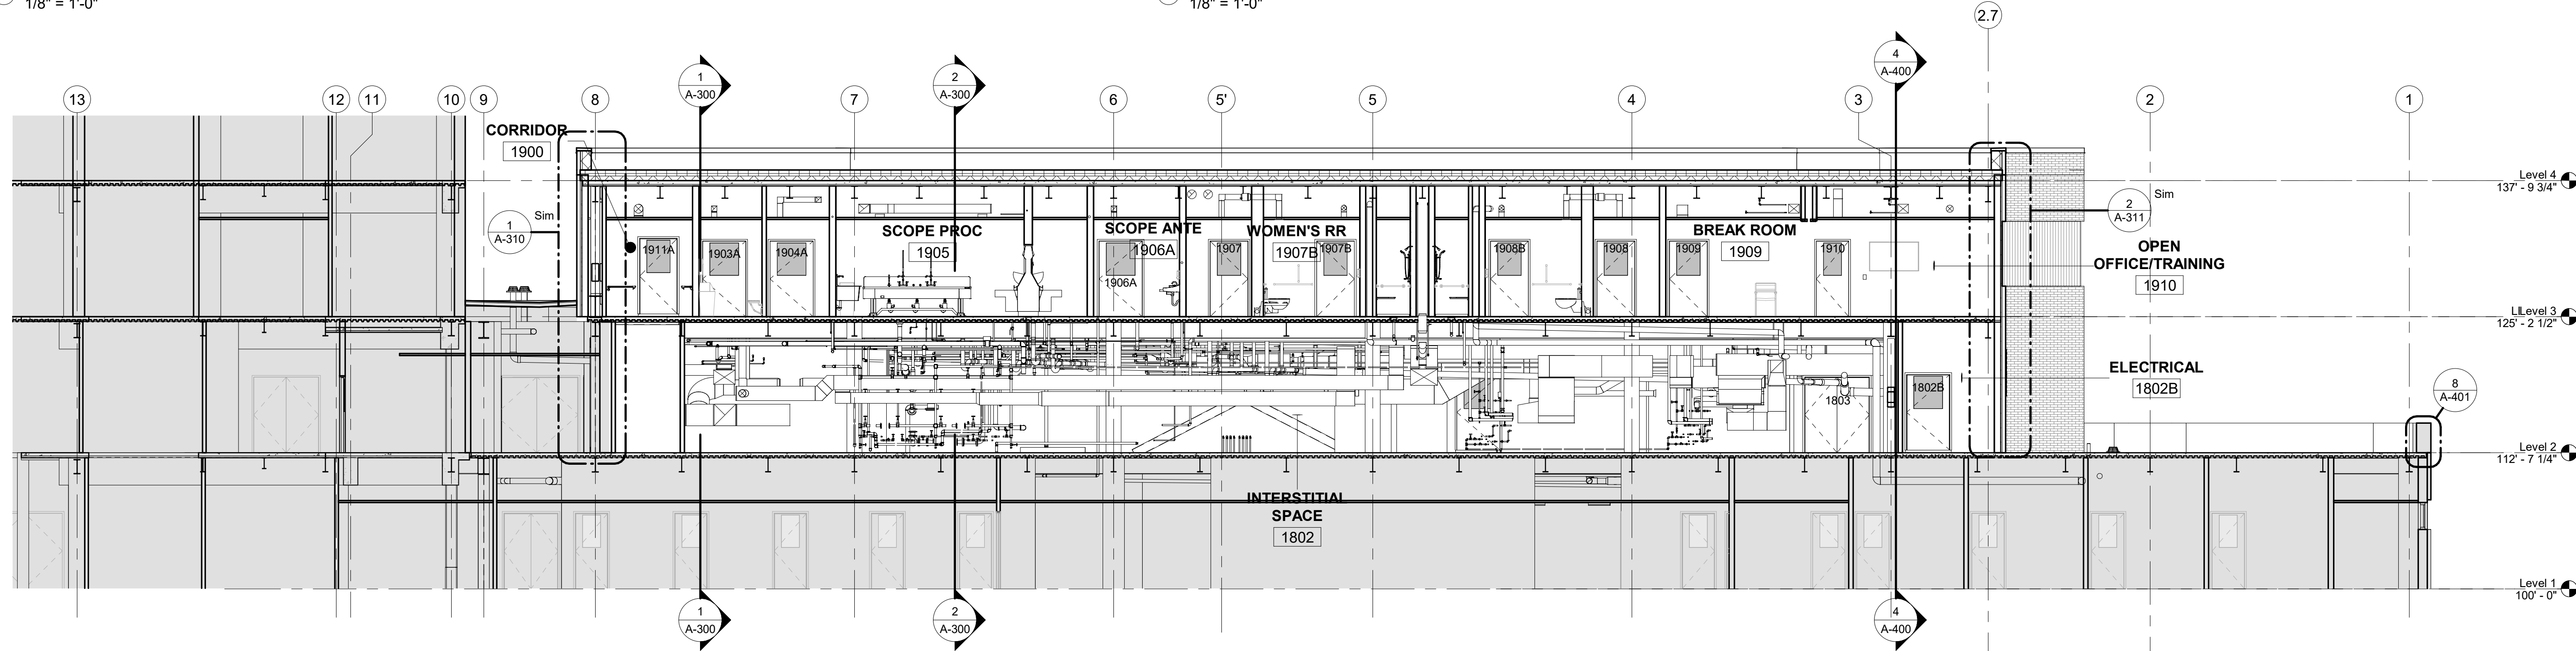

5 BUILDING SECTION
1/8" = 1'-0"

ROOM SCHEDULE, THIRD LEVEL

Number	Name
1802	INTERSTITIAL SPACE
1802A	ELECTRICAL
1802B	ELECTRICAL
1802C	ELECTRICAL
1803	STAIRS
1900	CORRIDOR
1900A	CORRIDOR
1900B	CORRIDOR
1901	OPEN SPACE
1902	IT
1902A	MECH CHASE
1903	ANTEROOM, SOILED TRANSITION / DROP-OFF
1904	SCOPE DROP OFF
1905	SCOPE PROC
1906A	SCOPE ANTE
1906B	SCOPE STG
1907	WOMEN'S LOCKER
1907A	WOMEN'S RR
1907B	WOMEN'S RR
1907C	WOMEN'S SHOWER
1908	MEN'S LOCKER
1908A	MEN'S RR
1908B	MEN'S RR
1908C	MEN'S SHOWER
1909	BREAK ROOM
1910	OPEN OFFICE/TRAINING
1911	ANTE VENDOR DROP OFF
1912	H2O
1913	CART PASS
1913A	MECH CHASE
1914	HAC
1915	DECON
1916	MANUAL CART WASH
1917	AUTOMATIC CART WASH AREA
1918	MECH CHASE
1919	CART DRY
1920	STERILIZATION
1921	STERILE STG
1921A	MECH CHASE
1923	PREP ASSEMBLY
1924	ANTE
1925	HAC
1926	CONFERENCE
1927	OPEN OFFICE
1928	OFFICE
1929	OFFICE
1930	COPIER ROOM
1931	STAIRS


CONSTRUCTION DOCUMENTS

COMPLIANCE REVIEW COMPLETED	2/23/2024
Revisions:	Date

CONSULTANTS:



TERRASITE DESIGN
1635 DEADWOOD AVENUE
RAPID CITY, SOUTH DAKOTA 57702
PH: (605) 791-1736

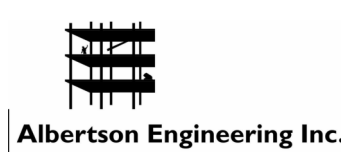

ALBERTSON ENGINEERING, INC.
315 NORTH MAIN AVENUE, SUITE 200
SIOUX FALLS, SOUTH DAKOTA 57104
PH: (605) 274-0880



FARRIS ENGINEERING
12700 WEST DODGE ROAD
OMAHA, NEBRASKA 68154
PH: (402) 330-5900



ARCHITECT



FOURFRONT DESIGN, INC.
517 7TH STREET
RAPID CITY, SOUTH DAKOTA 57701
PH: (605) 342-9470
FAX: (605) 342-2377
WWW.FOURFRONTDESIGN.COM

Drawing Title
BUILDING SECTIONS
Approved: Project Director
Omaha VA Medical Center

Project Title
**Design/Construct Sterile
Processing Service- Omaha VA
Medical Center**

Location
**4101 Woolworth Ave #4199
Omaha, Ne 68105**

Date
11/23/2020

Checked
JL

Drawn
JGC

Project Number
16.2330.A08

Building Number
25

Drawing Number
A-300




Dwg. 42 of 143

Office of
Construction
and Facilities
Management



GENERAL NOTES:

- SHEET SIZE FOR PROPER SCALE IS 30X42. CONTRACTOR SHALL NOT SCALE DRAWINGS BUT SHALL REQUEST THE DESIRED DIMENSIONS FROM THE ARCHITECT.
- SEE SHEET G-002 FOR GENERAL NOTES.
- APPLY 1 1/2" THICK FIREPROOFING AT ALL EXPOSED STEEL WITHIN INTERSTITIAL SPACE AND AT EXPOSED STEEL STRUCTURE ABOVE 3RD FLOOR CEILING, TYP.

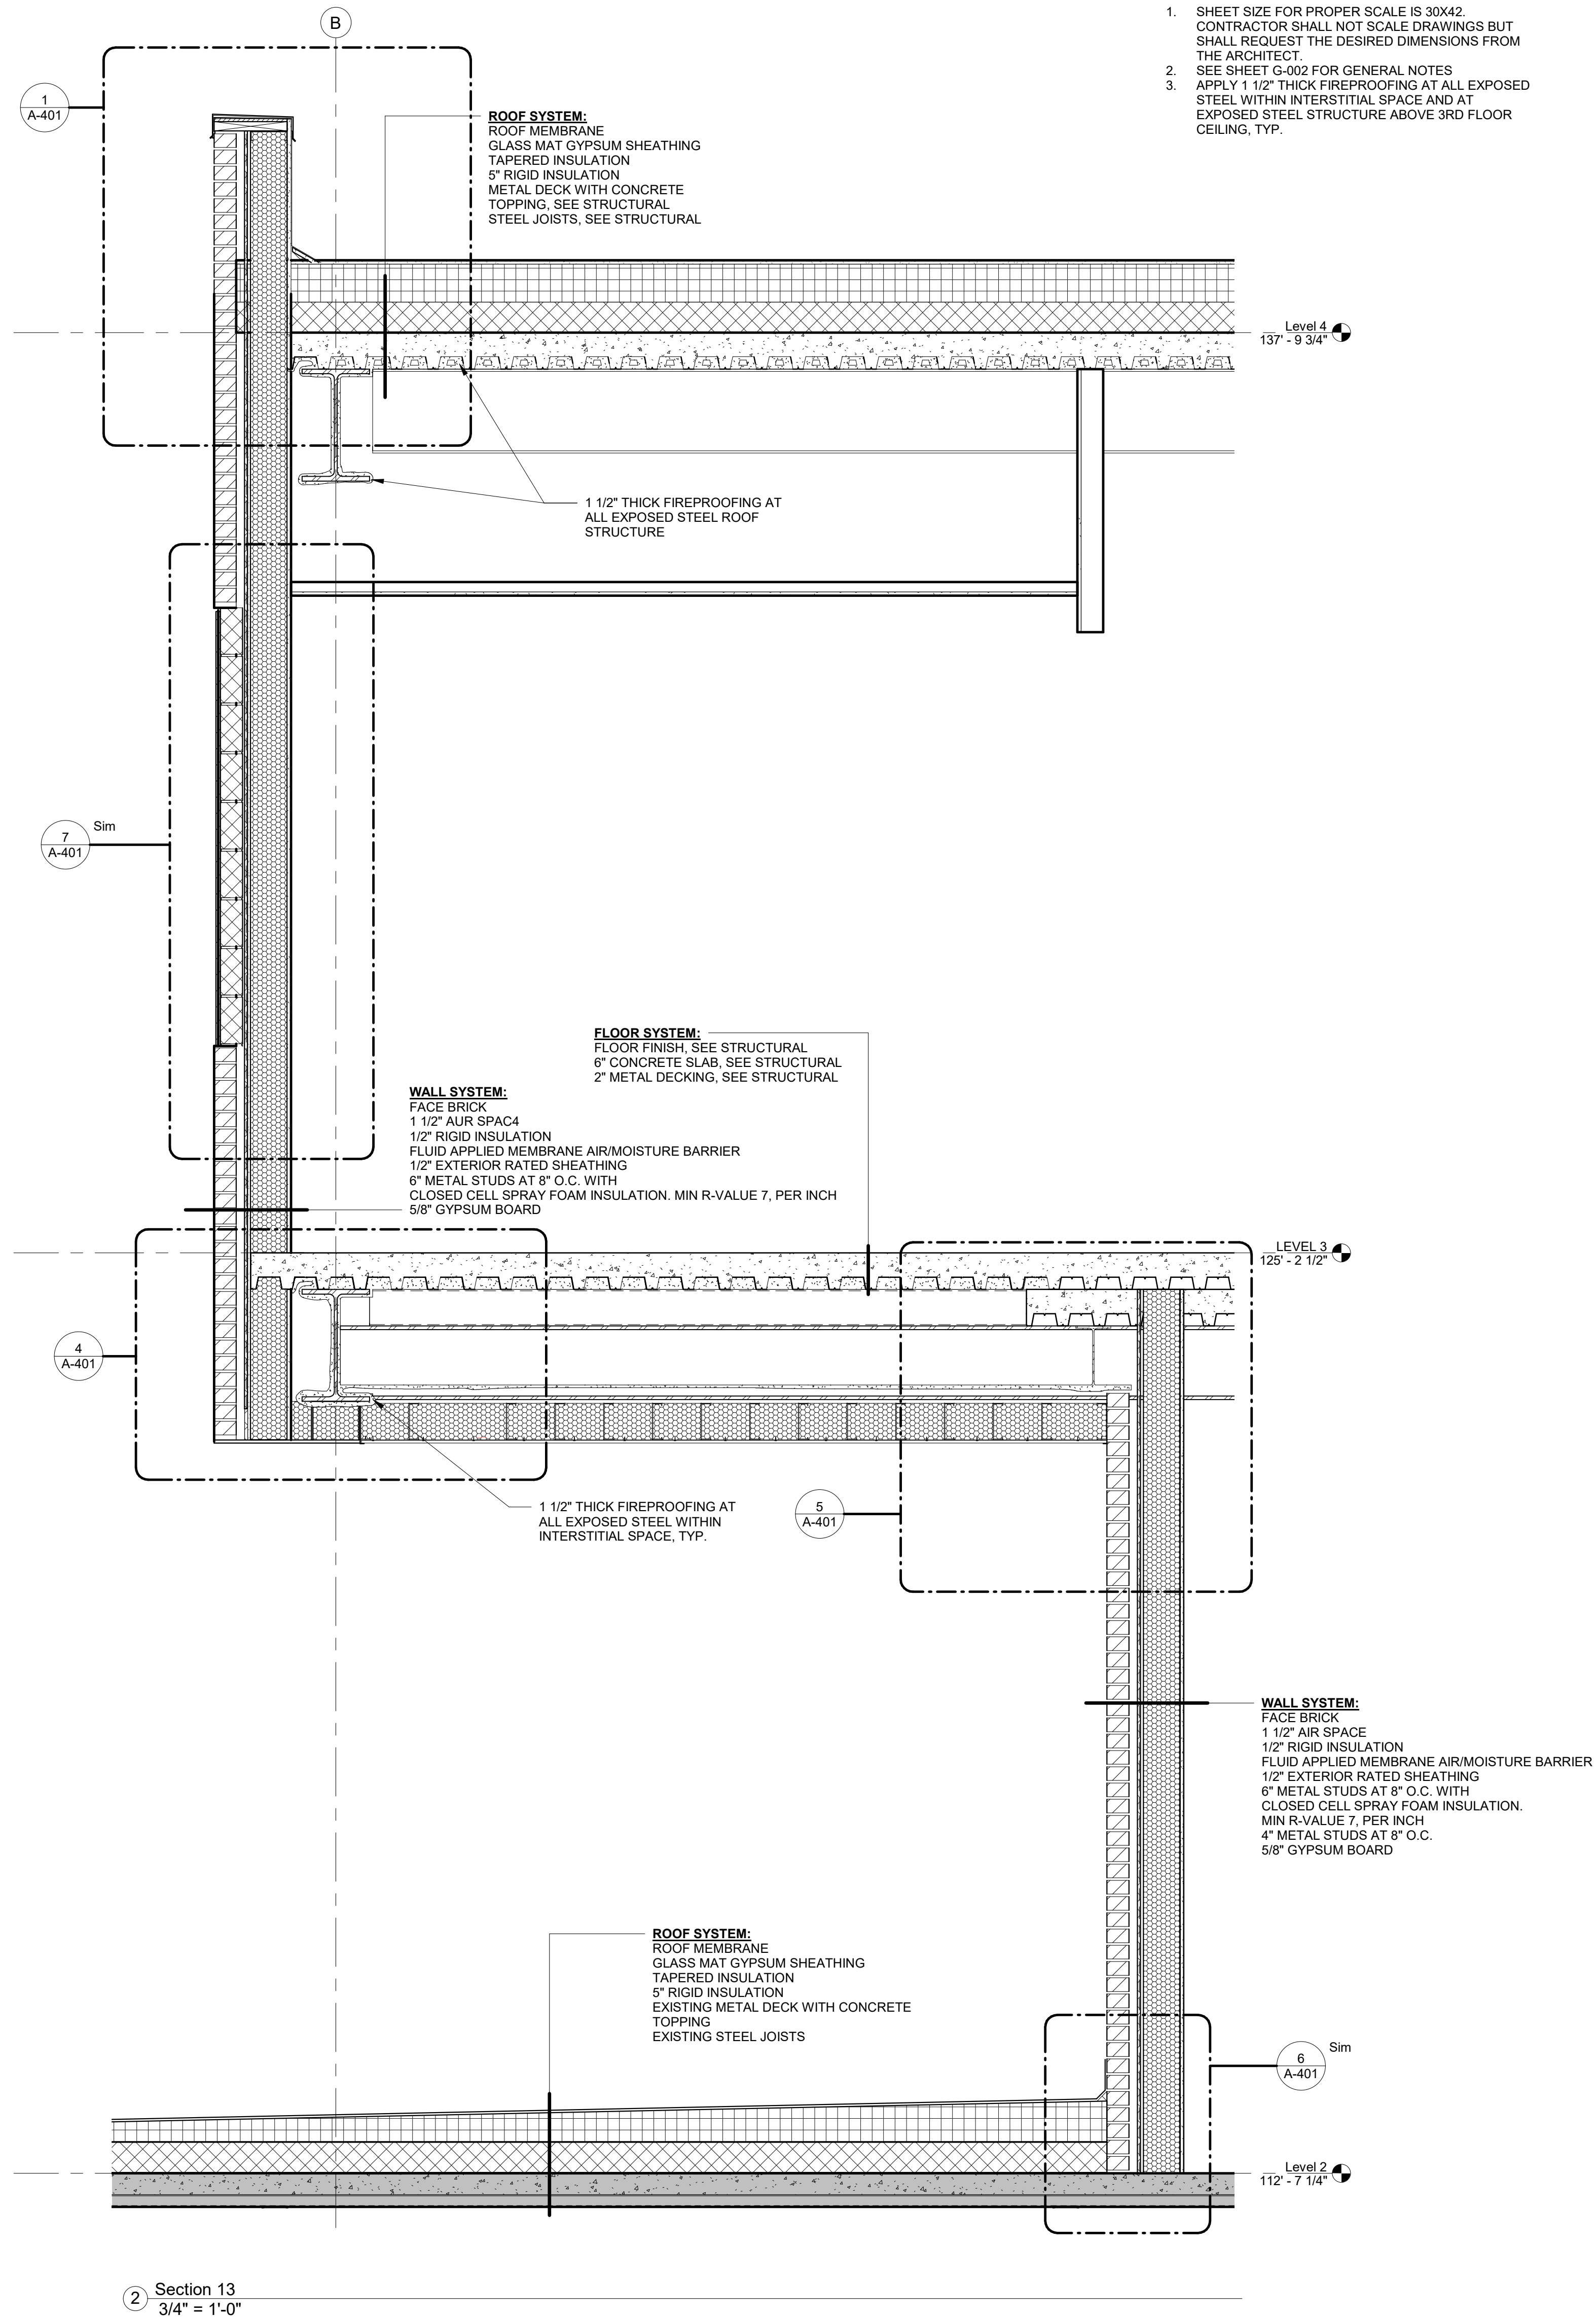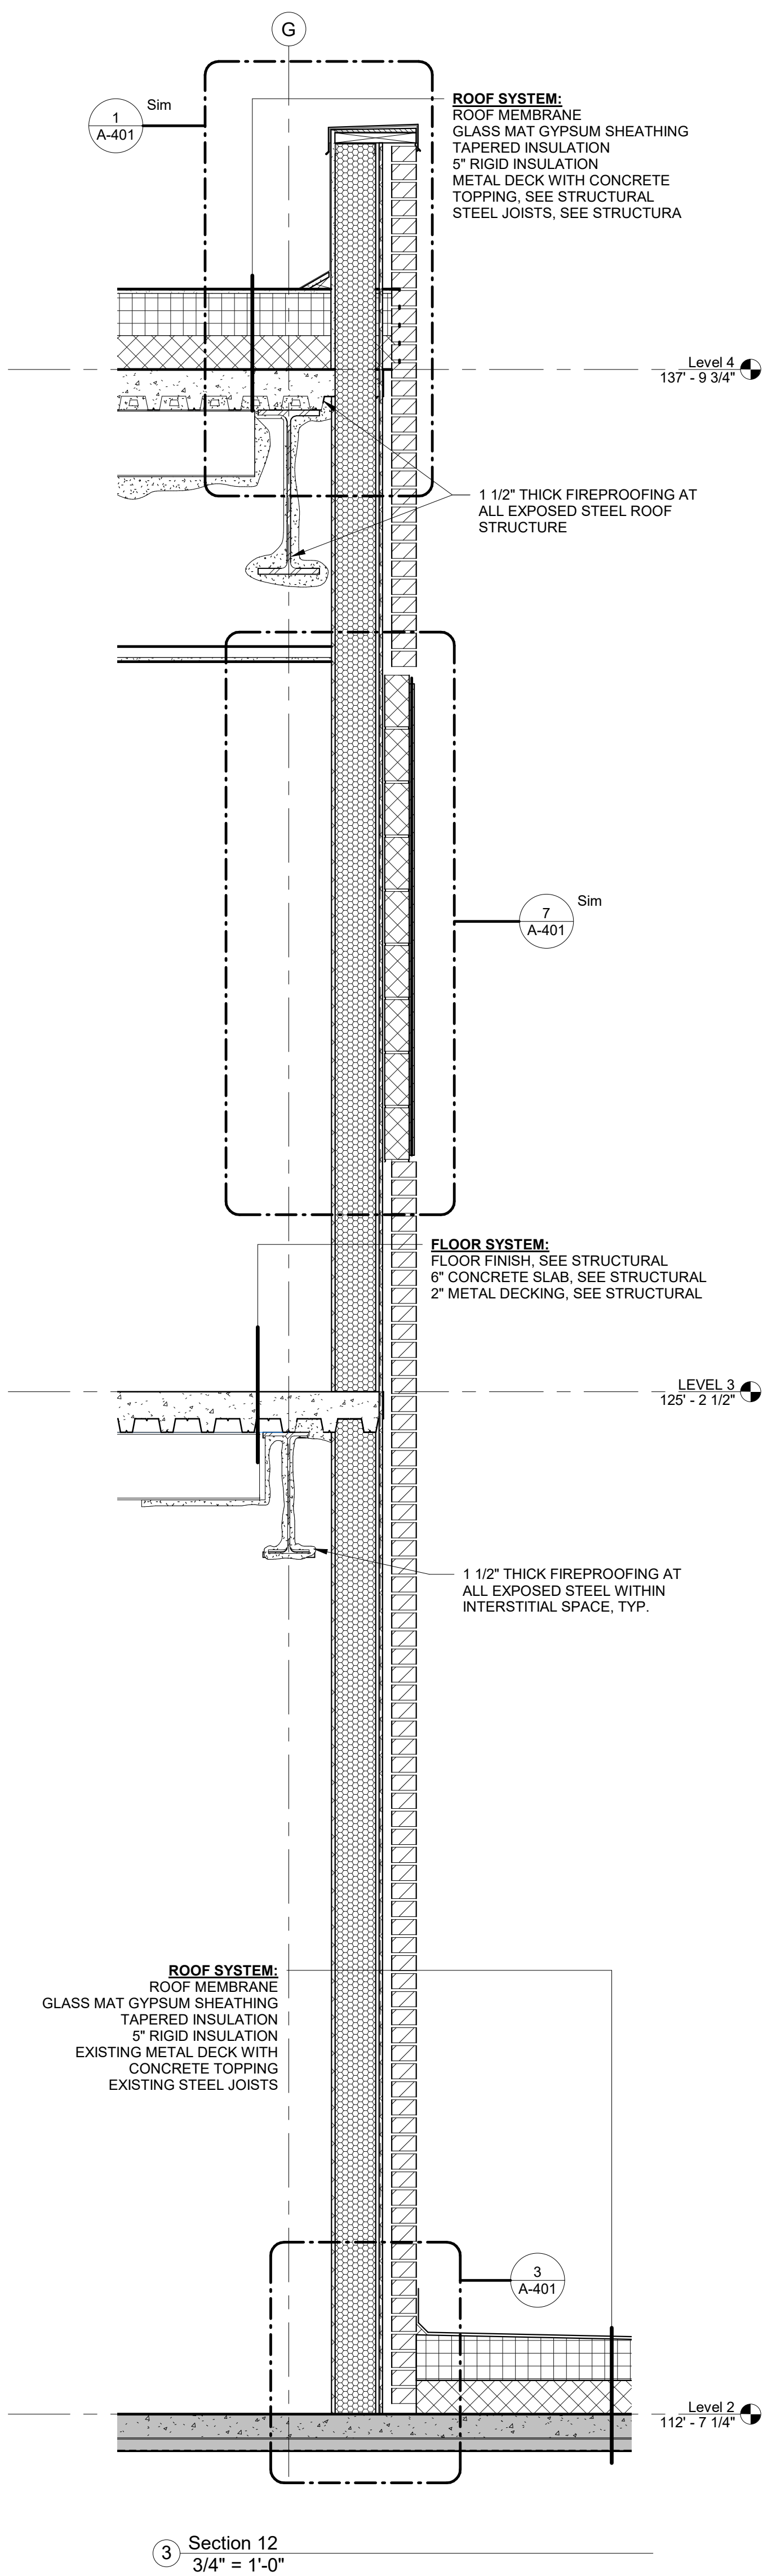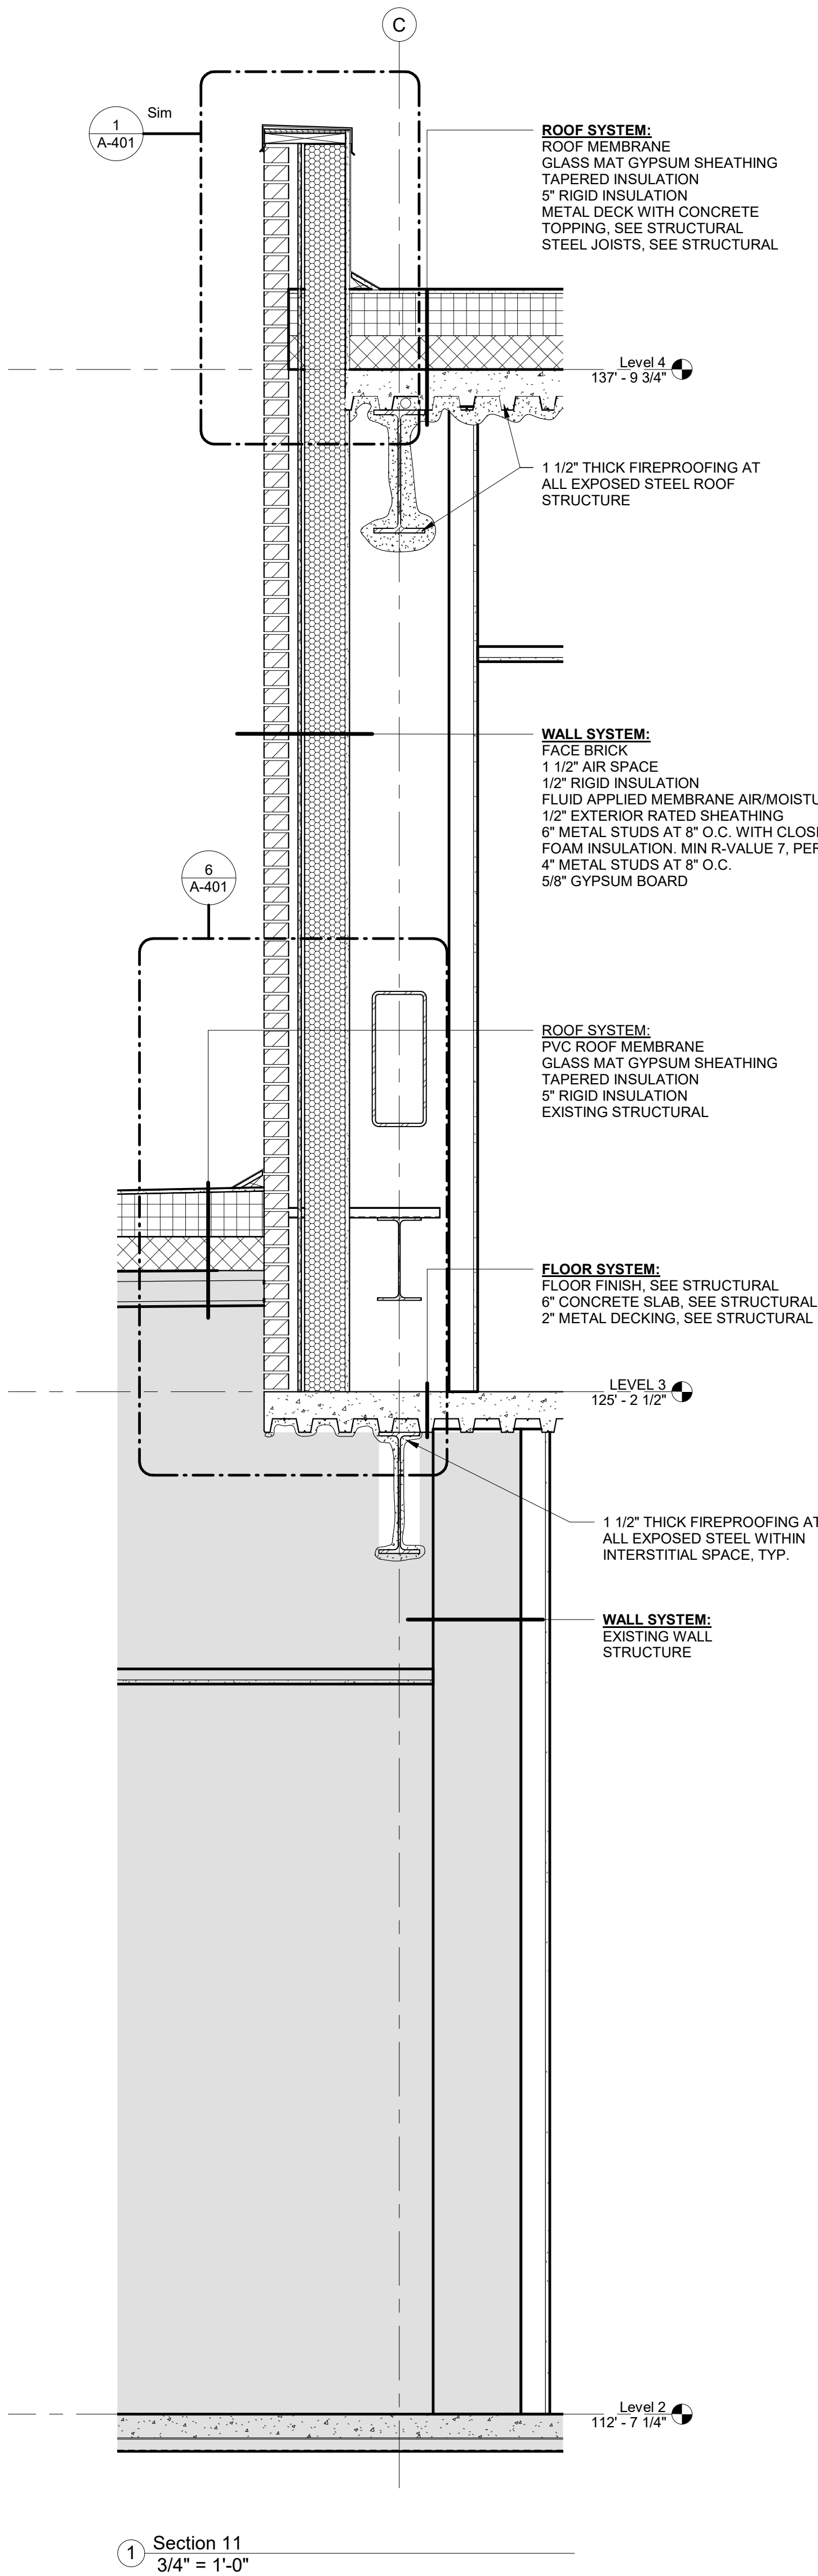

CONSTRUCTION DOCUMENTS

COMPLIANCE REVIEW COMPLETED	2/23/2024
Revisions:	Date

CONSULTANTS:

TERRASITE DESIGN
1635 DEADWOOD AVENUE
RAPID CITY, SOUTH DAKOTA 57702
PH: (605) 274-1736

Albertson Engineering Inc.

ALBERTSON ENGINEERING, INC.
315 NORTH MAIN AVENUE, SUITE 200
SIOUX FALLS, SOUTH DAKOTA 57104
PH: (605) 274-0880

FARRIS ENGINEERING
OMAHA [BRANCH] [RENT] [COUNCIL] [MEMBER]
FARRIS-NEBRASKA
PH: (402) 330-5900



ARCHITECT

FOURFRONT DESIGN, INC.
517 7TH STREET
RAPID CITY, SOUTH DAKOTA 57701
PH: (605) 342-9470
FAX: (605) 342-2377
WWW.FOURFRONTDESIGN.COM



Drawing Title	Project Title	Project Number
WALL SECTIONS	Design/Construct Sterile Processing Service- Omaha VA Medical Center	16.2330.A08
Approved: Project Director	Location	Building Number
Omaha VA Medical Center	4101 Woolworth Ave #4199 Omaha, Ne 68105	25
	Date	Checked
	11/23/2020	JL
		Drawn
		JGC

Drawing Number	Dwg. 43 of 143
A-310	

Office of Construction and Facilities Management
Department of Veterans Affairs

GENERAL NOTES:

1. SHEET SIZE FOR PROPER SCALE IS 30X42. CONTRACTOR SHALL NOT SCALE DRAWINGS BUT SHALL REQUEST THE DESIRED DIMENSIONS FROM THE ARCHITECT.
2. SEE SHEET G-002 FOR GENERAL NOTES.
3. APPLY 1 1/2" THICK FIREPROOFING AT ALL EXPOSED STEEL WITHIN INTERSTITIAL SPACE AND AT EXPOSED STEEL STRUCTURE ABOVE 3RD FLOOR CEILING, TYP.

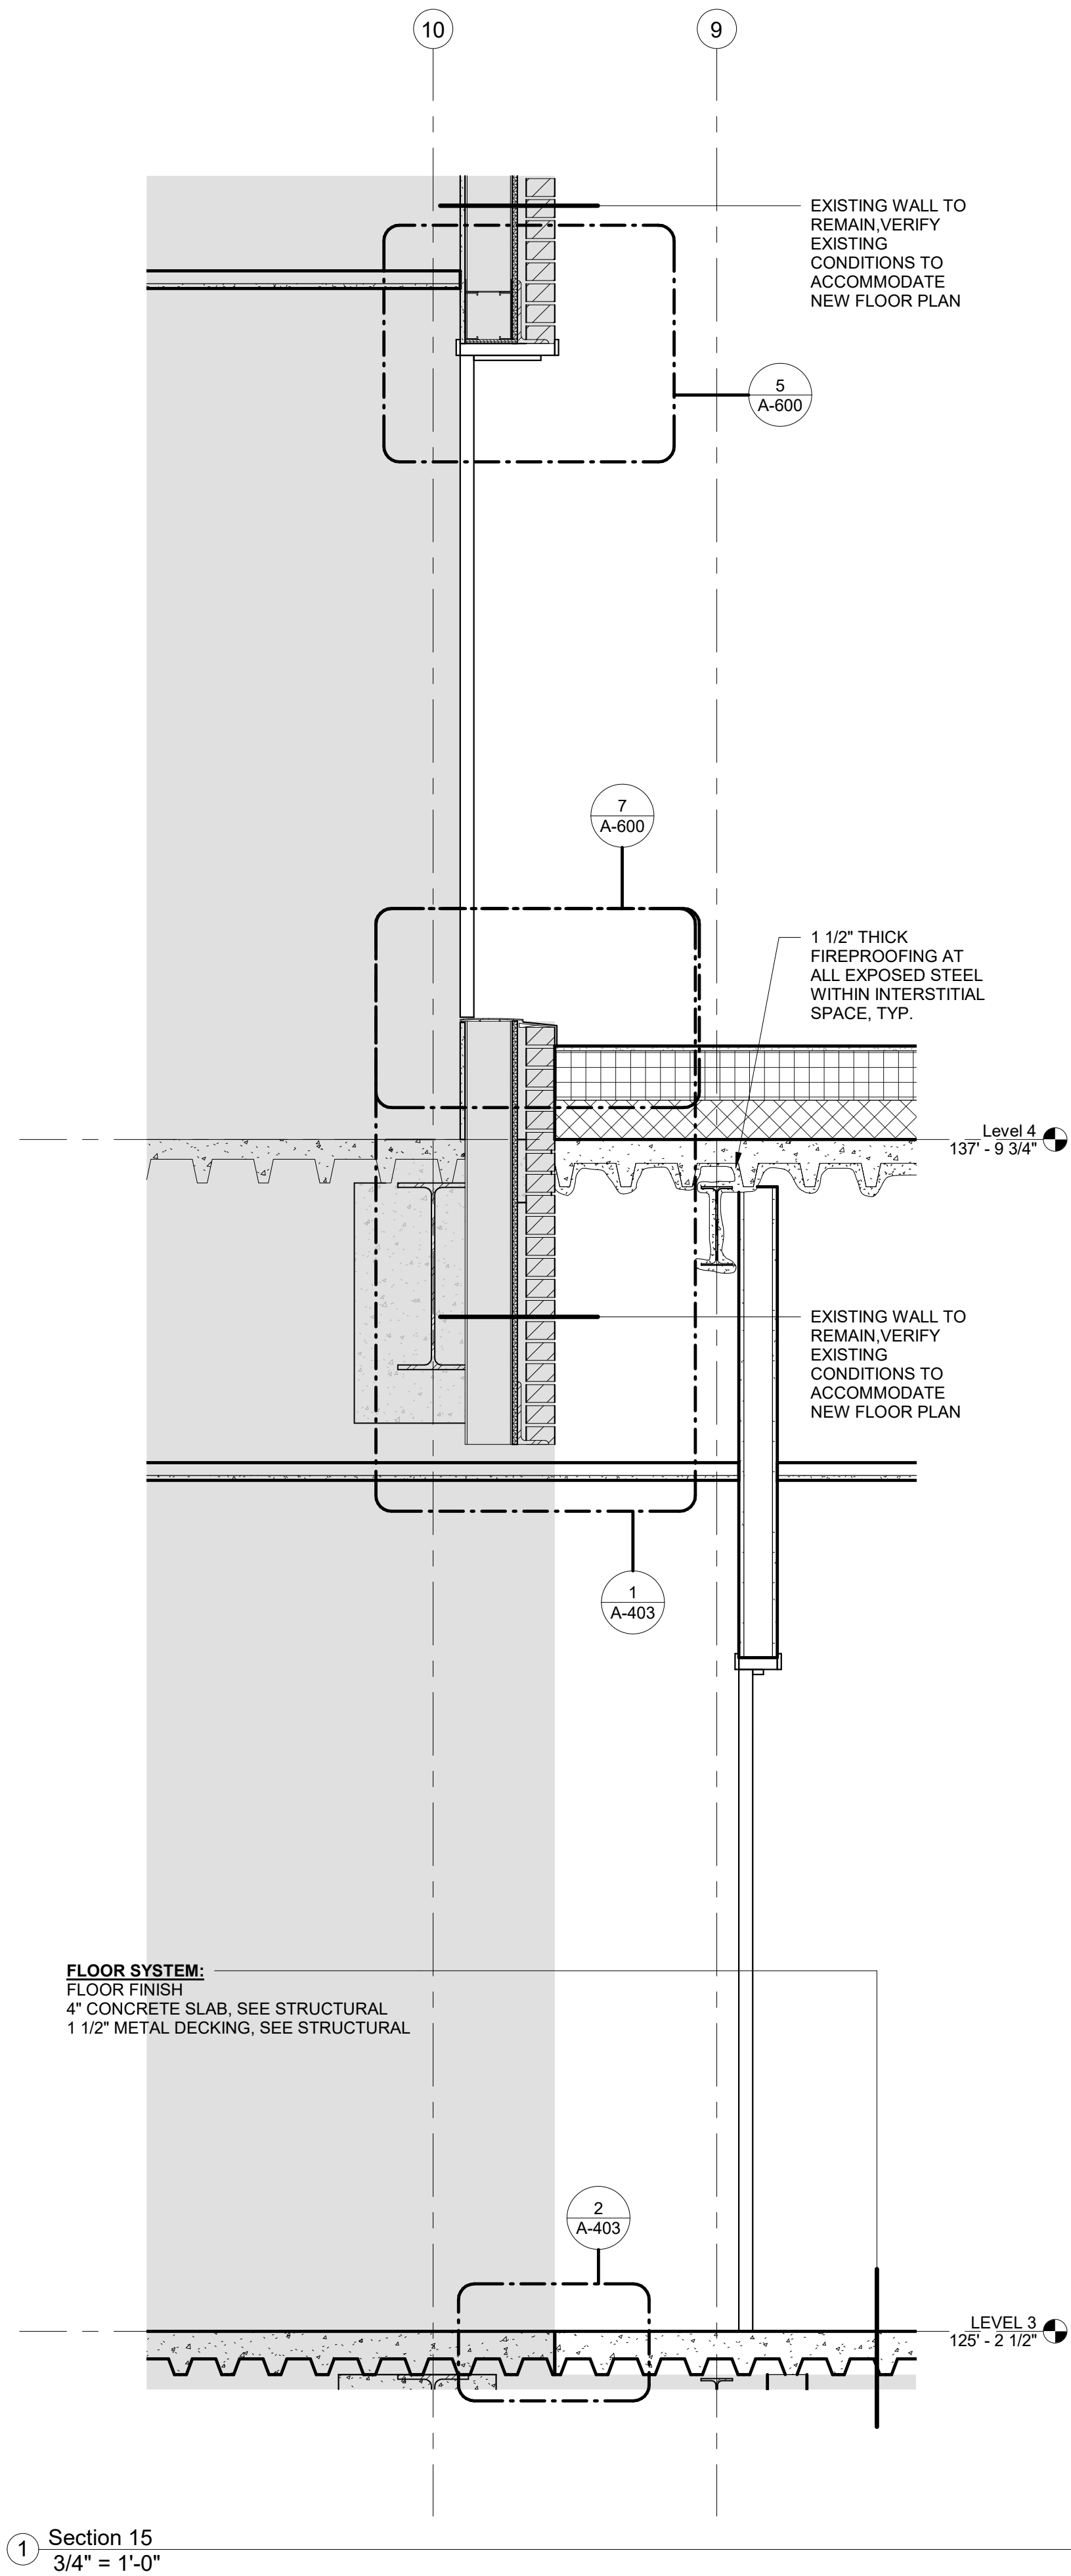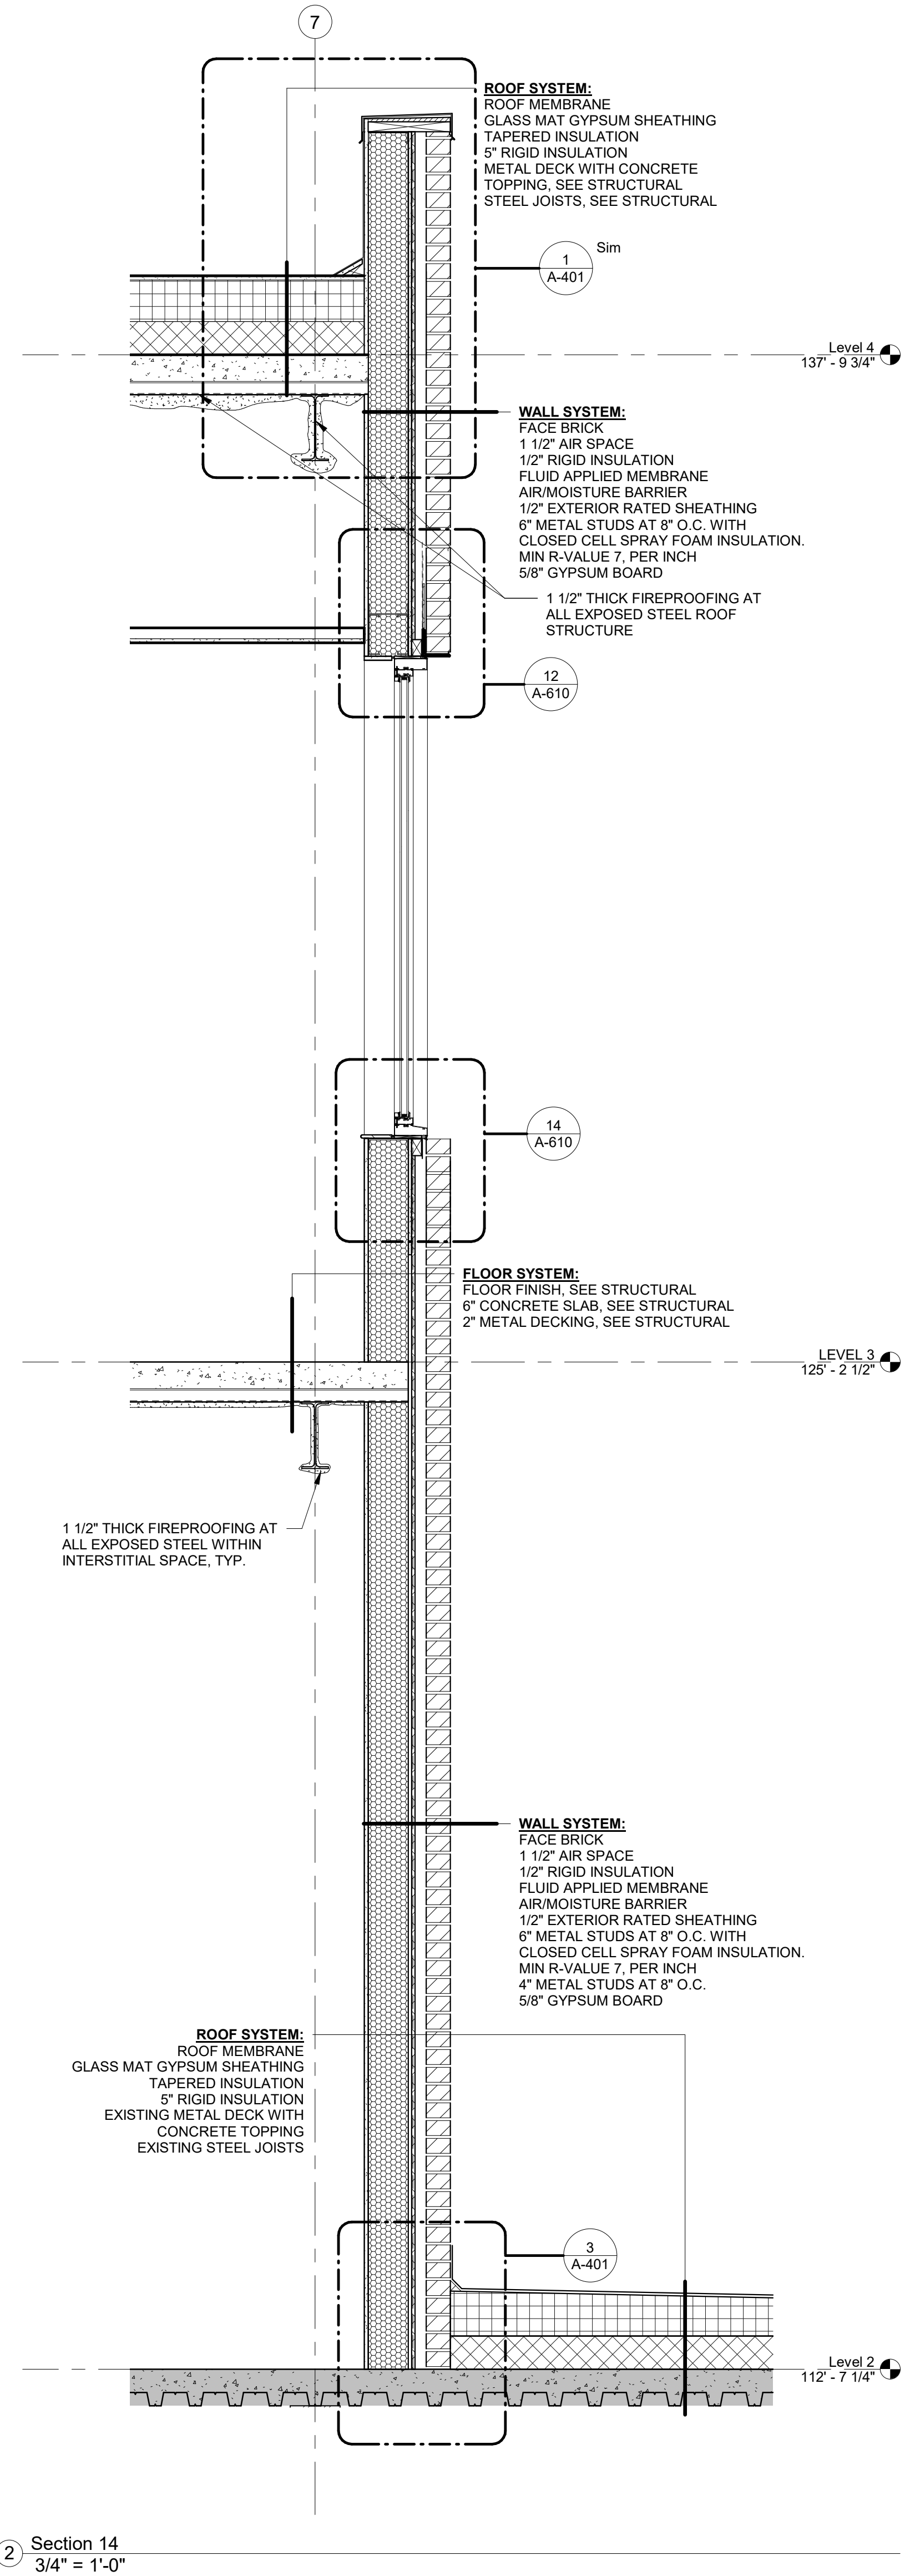

CONSTRUCTION DOCUMENTS

COMPLIANCE REVIEW COMPLETED	2/23/2024
Revisions:	Date

CONSULTANTS:	
TERRASITE DESIGN 1635 DEADWOOD AVENUE RAPID CITY, SOUTH DAKOTA 57702 PH: (605) 791-1736	ALBERTSON ENGINEERING, INC. 315 NORTH MAIN AVENUE, SUITE 200 SIOUX FALLS, SOUTH DAKOTA 57104 PH: (605) 274-0880
FARRIS ENGINEERING OMAHA (BRANCH) SENECA COUNCIL BLUFFS 1123 S. 16TH ST. OMAHA, NEBRASKA 68104 PH: (402) 330-5900	



ARCHITECT	
FOURFRONT DESIGN, INC. 517 7TH STREET RAPID CITY, SOUTH DAKOTA 57701 PH: (605) 342-9470 FAX: (605) 342-2377 WWW.FOURFRONTDESIGN.COM	

Drawing Title	WALL SECTIONS
Approved: Project Director	Omaha VA Medical Center

Project Title	Design/Construct Sterile Processing Service- Omaha VA Medical Center
Location	4101 Woolworth Ave #4199 Omaha, Ne 68105
Date	11/23/2020
Checked	Checker
Drawn	Author
Project Number	16.2330.A08
Building Number	25
Drawing Number	A-311
Dwg. 44 of 143	

Office of Construction and Facilities Management
Department of Veterans Affairs

GENERAL NOTES:

1. SHEET SIZE FOR PROPER SCALE IS 30X42. CONTRACTOR SHALL NOT SCALE DRAWINGS BUT SHALL REQUEST THE DESIRED DIMENSIONS FROM THE ARCHITECT.
2. SEE SHEET G-002 FOR GENERAL NOTES.
3. APPLY 1 1/2" THICK FIREPROOFING AT ALL EXPOSED STEEL WITHIN INTERSTITIAL SPACE AND AT EXPOSED STEEL STRUCTURE ABOVE 3RD FLOOR CEILING, TYP.

SHEET SPECIFIC NOTES:

1. REFERENCE STRUCTURAL FOR STAIR DETAILS.
2. ALL STRUCTURAL STEEL AND TUBING IS TO BE PAINTED. SEE STRUCTURAL REFERENCE 099000.

10 ENLARGED STAIR FLOOR PLAN - LEVEL 1
1/4" = 1'-0"

1 ENLARGED STAIR FLOOR PLAN - LEVEL 2
1/4" = 1'-0"

2 ENLARGED STAIR FLOOR PLAN - LEVEL 3
1/4" = 1'-0"

3 STAIRSECTION
1/4" = 1'-0"

5 TYPICAL STAIR LANDING SECTION
1" = 1'-0"

4 STAIRSECTION
1/4" = 1'-0"

6 TYPICAL STAIR RAIL SECTION
1" = 1'-0"

9 STAIR - GUARD AT CENTER OF FIGHT
1 1/2" = 1'-0"

8 TYPICAL HANDRAIL DETAIL
3" = 1'-0"

7 TYPICAL STAIR SECTION
1 1/2" = 1'-0"

CONSTRUCTION DOCUMENTS

CONSULTANTS:

TERRASITE DESIGN
1635 DEADWOOD AVENUE
RAPID CITY, SOUTH DAKOTA 57702
PH: (605) 791-1736

Albertson Engineering Inc.

ALBERTSON ENGINEERING, INC.
315 NORTH MAIN AVENUE, SUITE 200
SIOUX FALLS, SOUTH DAKOTA 57104
PH: (605) 274-0880

FARRIS ENGINEERING
OMAHA (BRANCH) 10011
FARRIS ENGINEERING
12700 WEST DODGE ROAD
OMAHA, NEBRASKA 68154
PH: (402) 330-5900



ARCHITECT

FOURFRONT DESIGN, INC.
517 7TH STREET
RAPID CITY, SOUTH DAKOTA 57701
PH: (605) 342-9470
FAX: (605) 342-2377
WWW.FOURFRONTDESIGN.COM

Drawing Title
**ENLARGED STAIR PLANS, SECTIONS
AND DETAILS**

Approved: Project Director
Omaha VA Medical Center

Project Title
**Design/Construct Sterile
Processing Service- Omaha VA
Medical Center**

Location
**4101 Woolworth Ave #4199
Omaha, Ne 68105**

Date
11/23/2020

Checked
JL

Drawn
JGC

Project Number
16.2330.A08

 
 
 
 
Building Number
25


Drawing Number
A-400

Dwg. 45 of 143

Office of
Construction
and Facilities
Management

**Department of
Veterans Affairs**



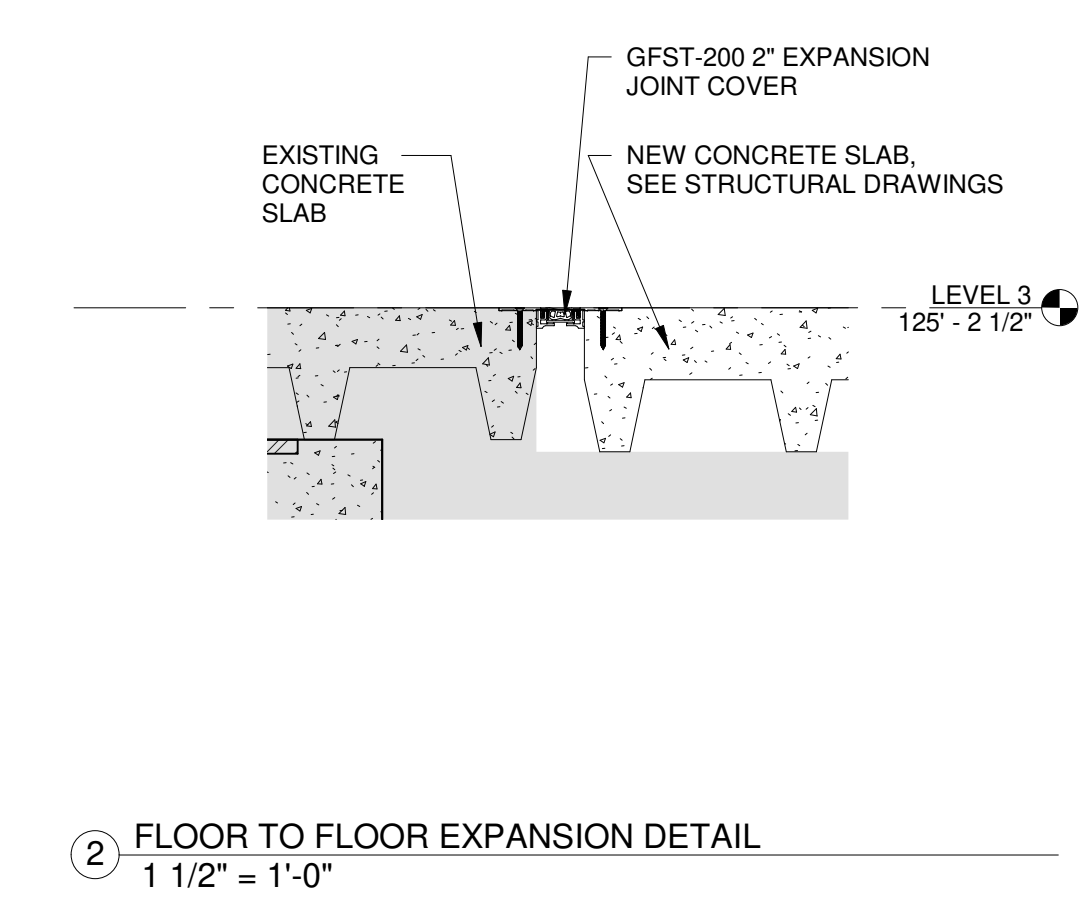VA FORM 08-6231

6/1/2025 5:13:06 PM


VA FORM 08-6231

COMPLIANCY REVIEW COMPLETED	2/23/2024
Revisions:	Date

CONSULTANTS:



TERRASITE DESIGN
1635 DEADWOOD AVENUE
RAPID CITY, SOUTH DAKOTA 57702
PH: (605) 791-1736

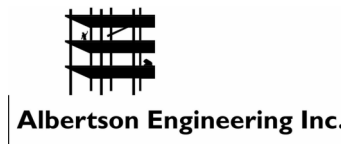

ALBERTSON ENGINEERING, INC.
315 NORTH MAIN AVENUE, SUITE 200
SIOUX FALLS, SOUTH DAKOTA 57104
PH: (605) 274-0880



FARRIS ENGINEERING
12700 WEST DODGE ROAD
OMAHA, NEBRASKA 68154
PH: (402) 330-5900



ARCHITECT





FOURFRONT DESIGN, INC.
517 7TH STREET
RAPID CITY, SOUTH DAKOTA 57701
PH: (605) 342-9470
FAX: (605) 342-2377
WWW.FOURFRONTDESIGN.COM


Drawing Title	Project Title	Project Number
SECTION DETAILS	Design/Construct Sterile Processing Service- Omaha VA Medical Center	16.2330.A08
Approved: Project Director	Location	Building Number
Omaha VA Medical Center	4101 Woolworth Ave #4199 Omaha, Ne 68105	25
	Date	Checked
	11/23/2020	JL
		Drawn
		JGC

Drawing Number	Dwg. 48 of 143
A-403	

Office of Construction and Facilities Management	Department of Veterans Affairs
--	--------------------------------

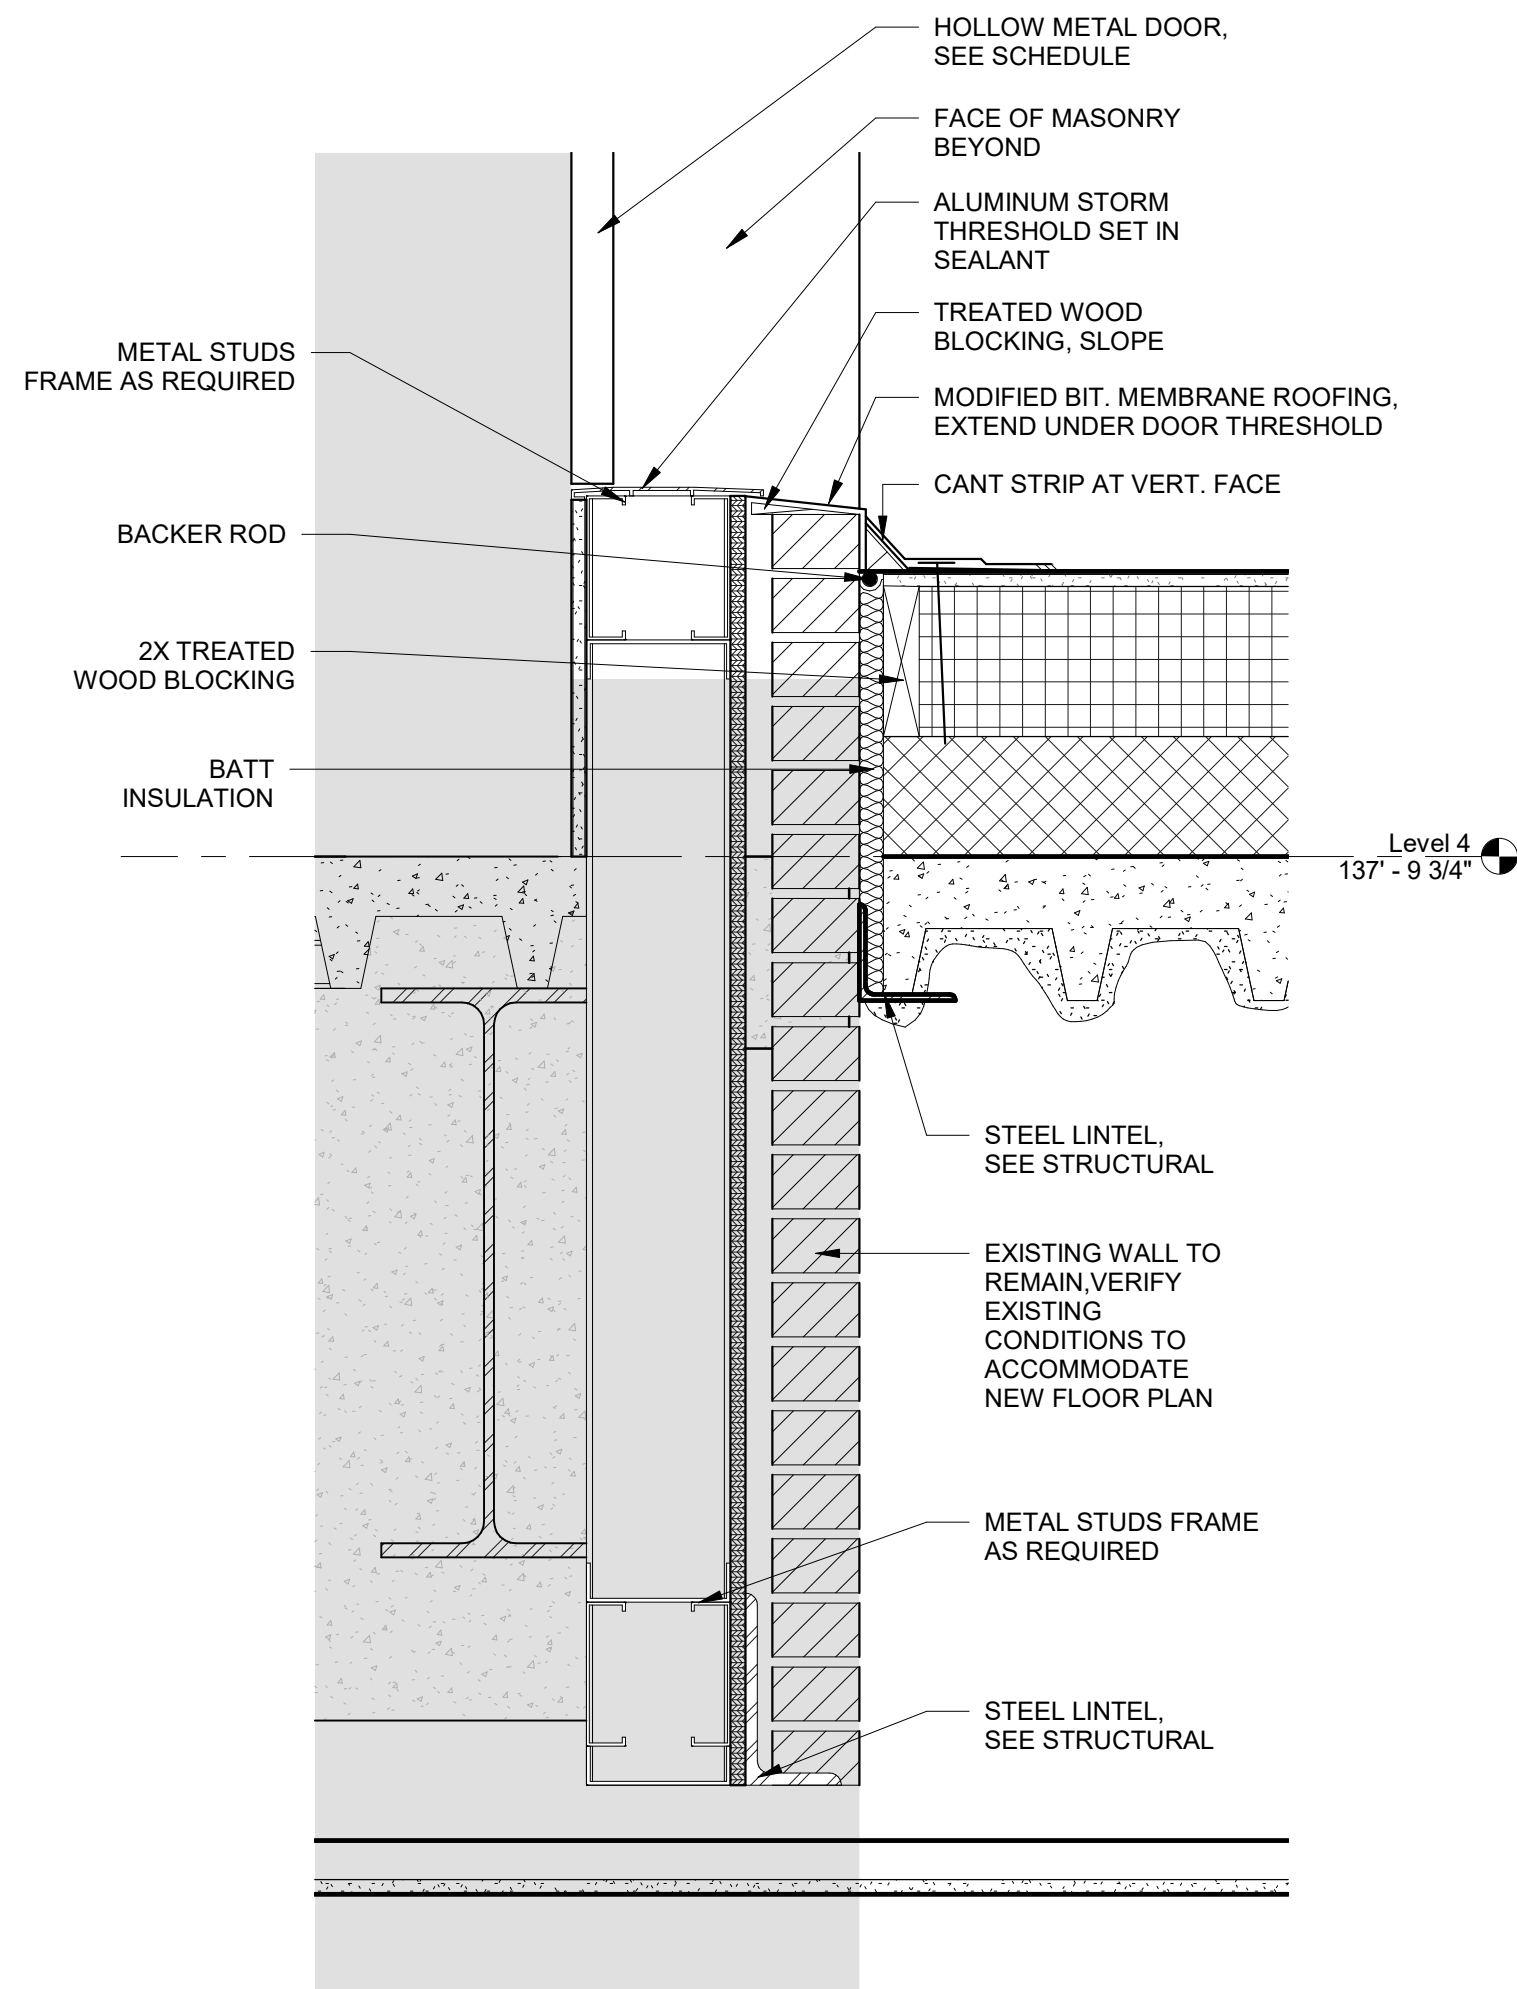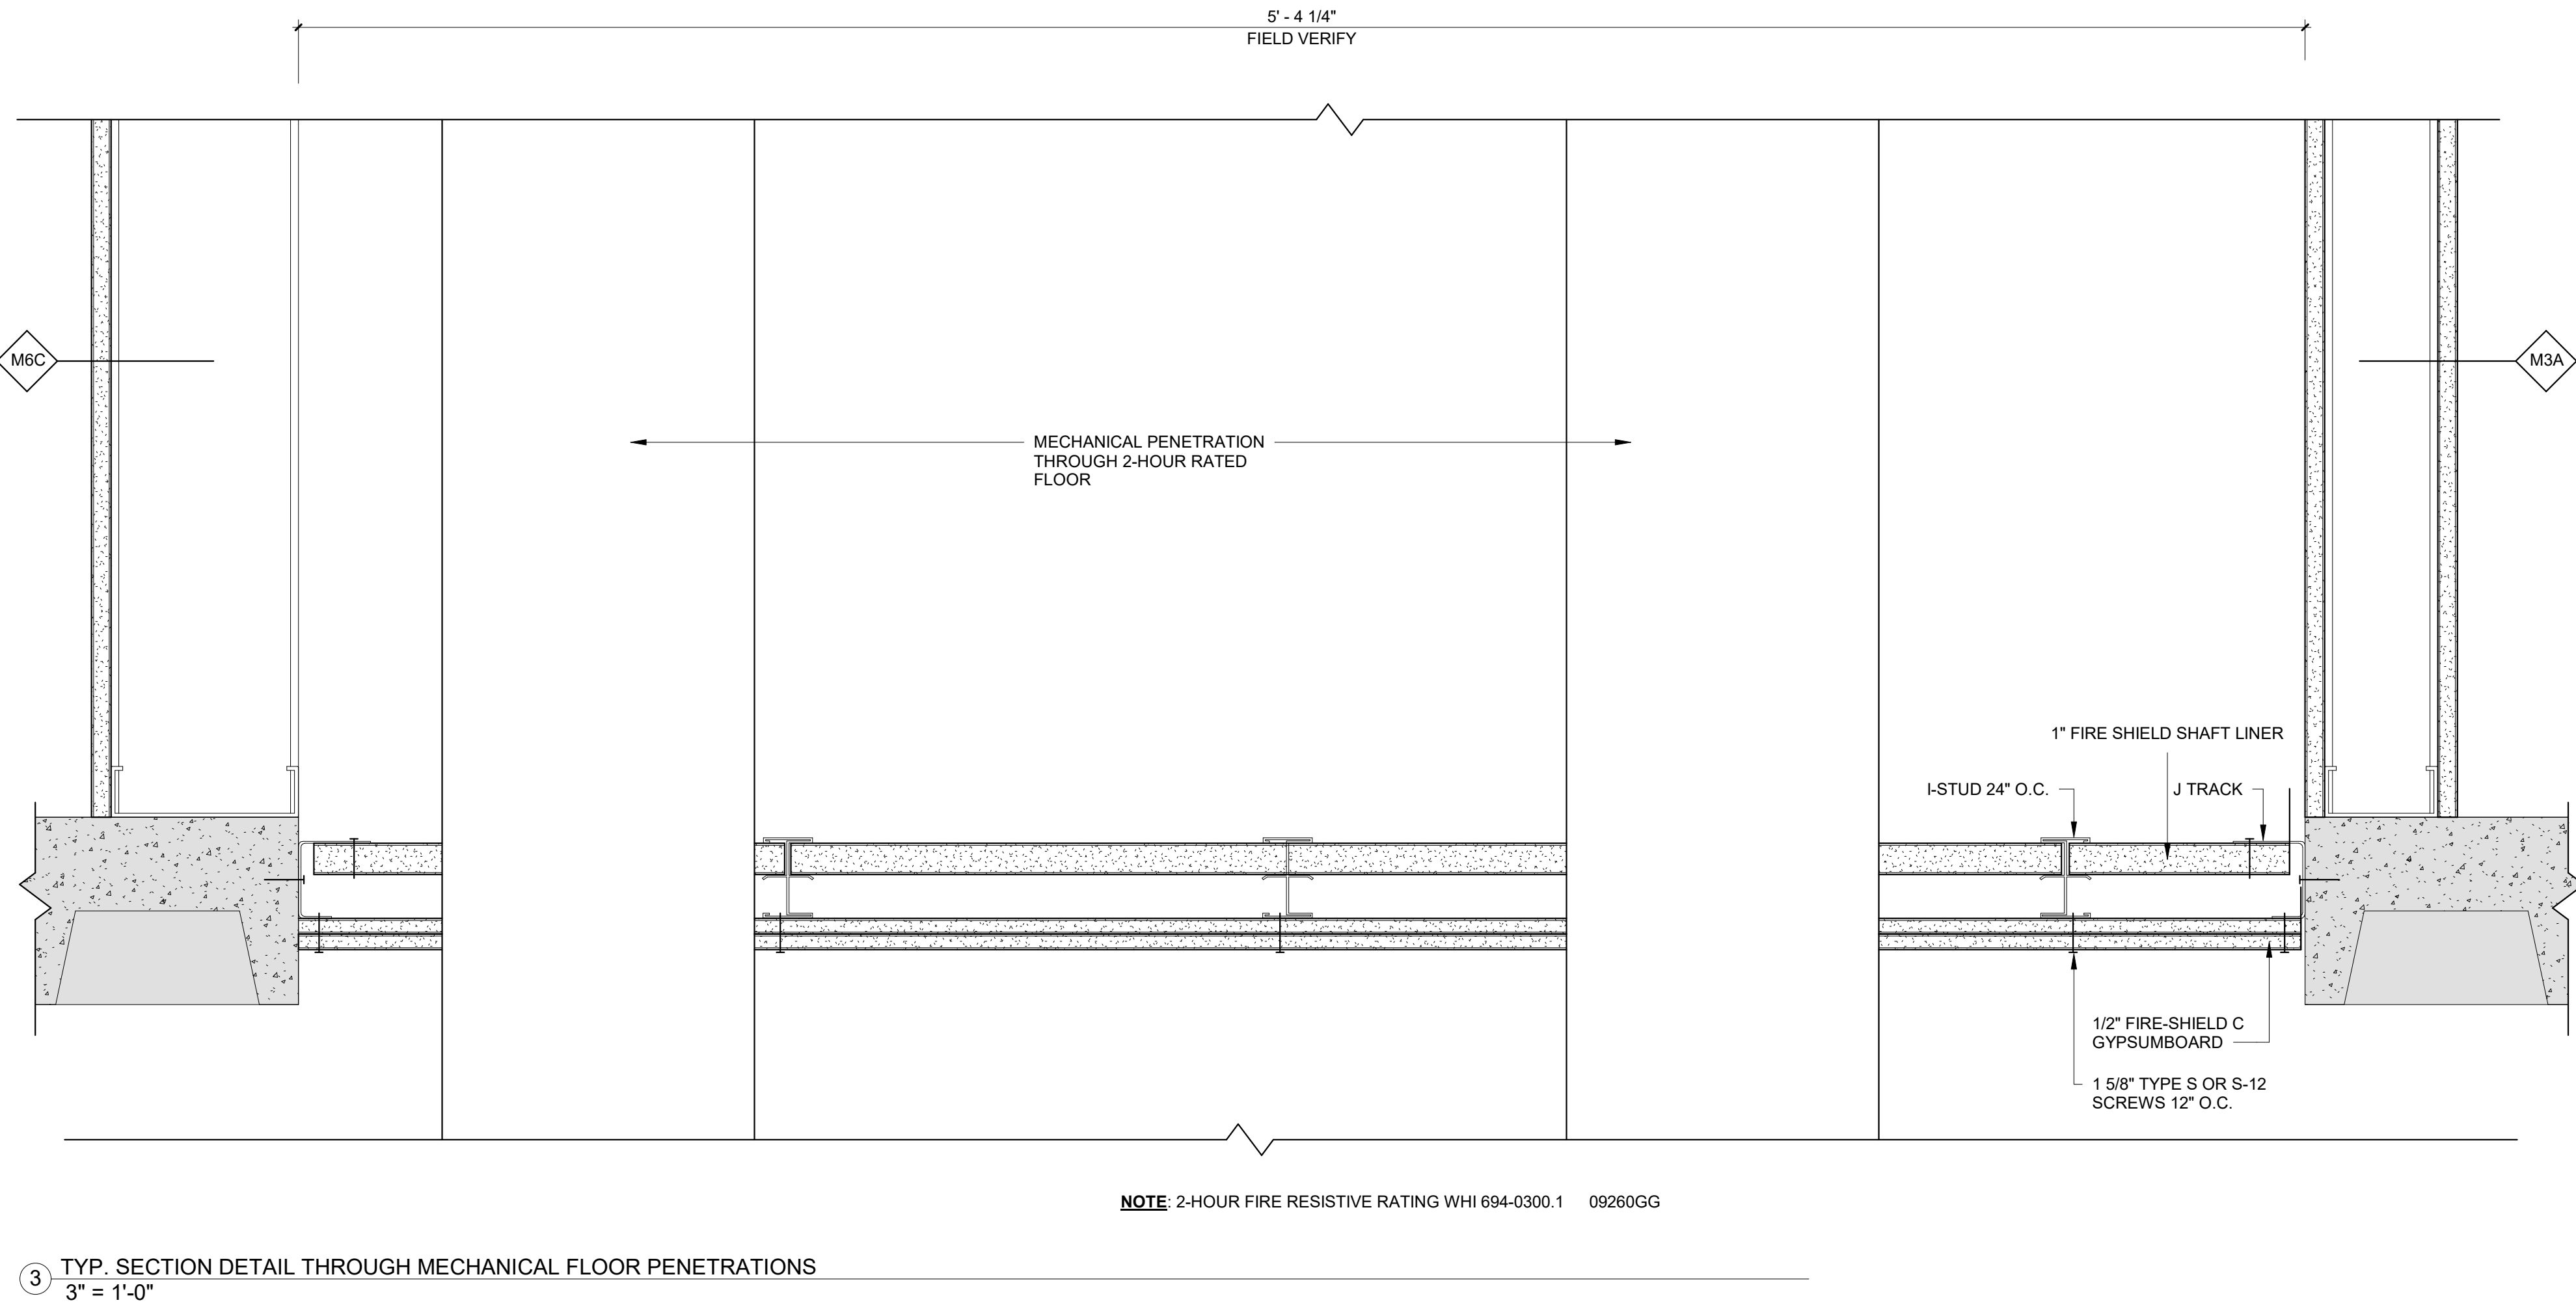


1 EXTERIOR DOOR - SILL DETAIL
1 1/2" = 1'-0"

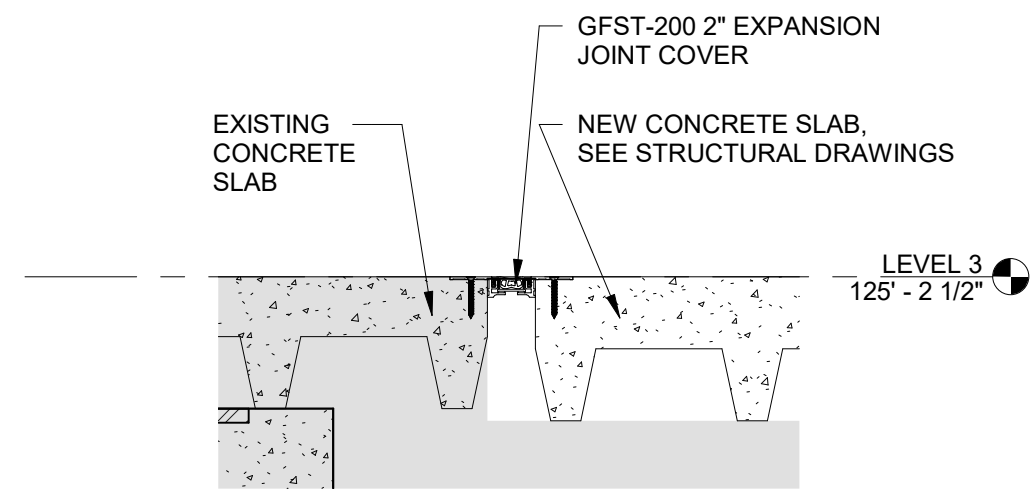


2 FLOOR TO FLOOR EXPANSION DETAIL
1 1/2" = 1'-0"

CONSTRUCTION DOCUMENTS


one and one half inches = one foot
three quarters inch = one foot one inch = one foot
three eighths inch = one foot one half inch = one foot
one quarter inch = one foot
one eighth inch = one foot
one sixteenth inch = one foot

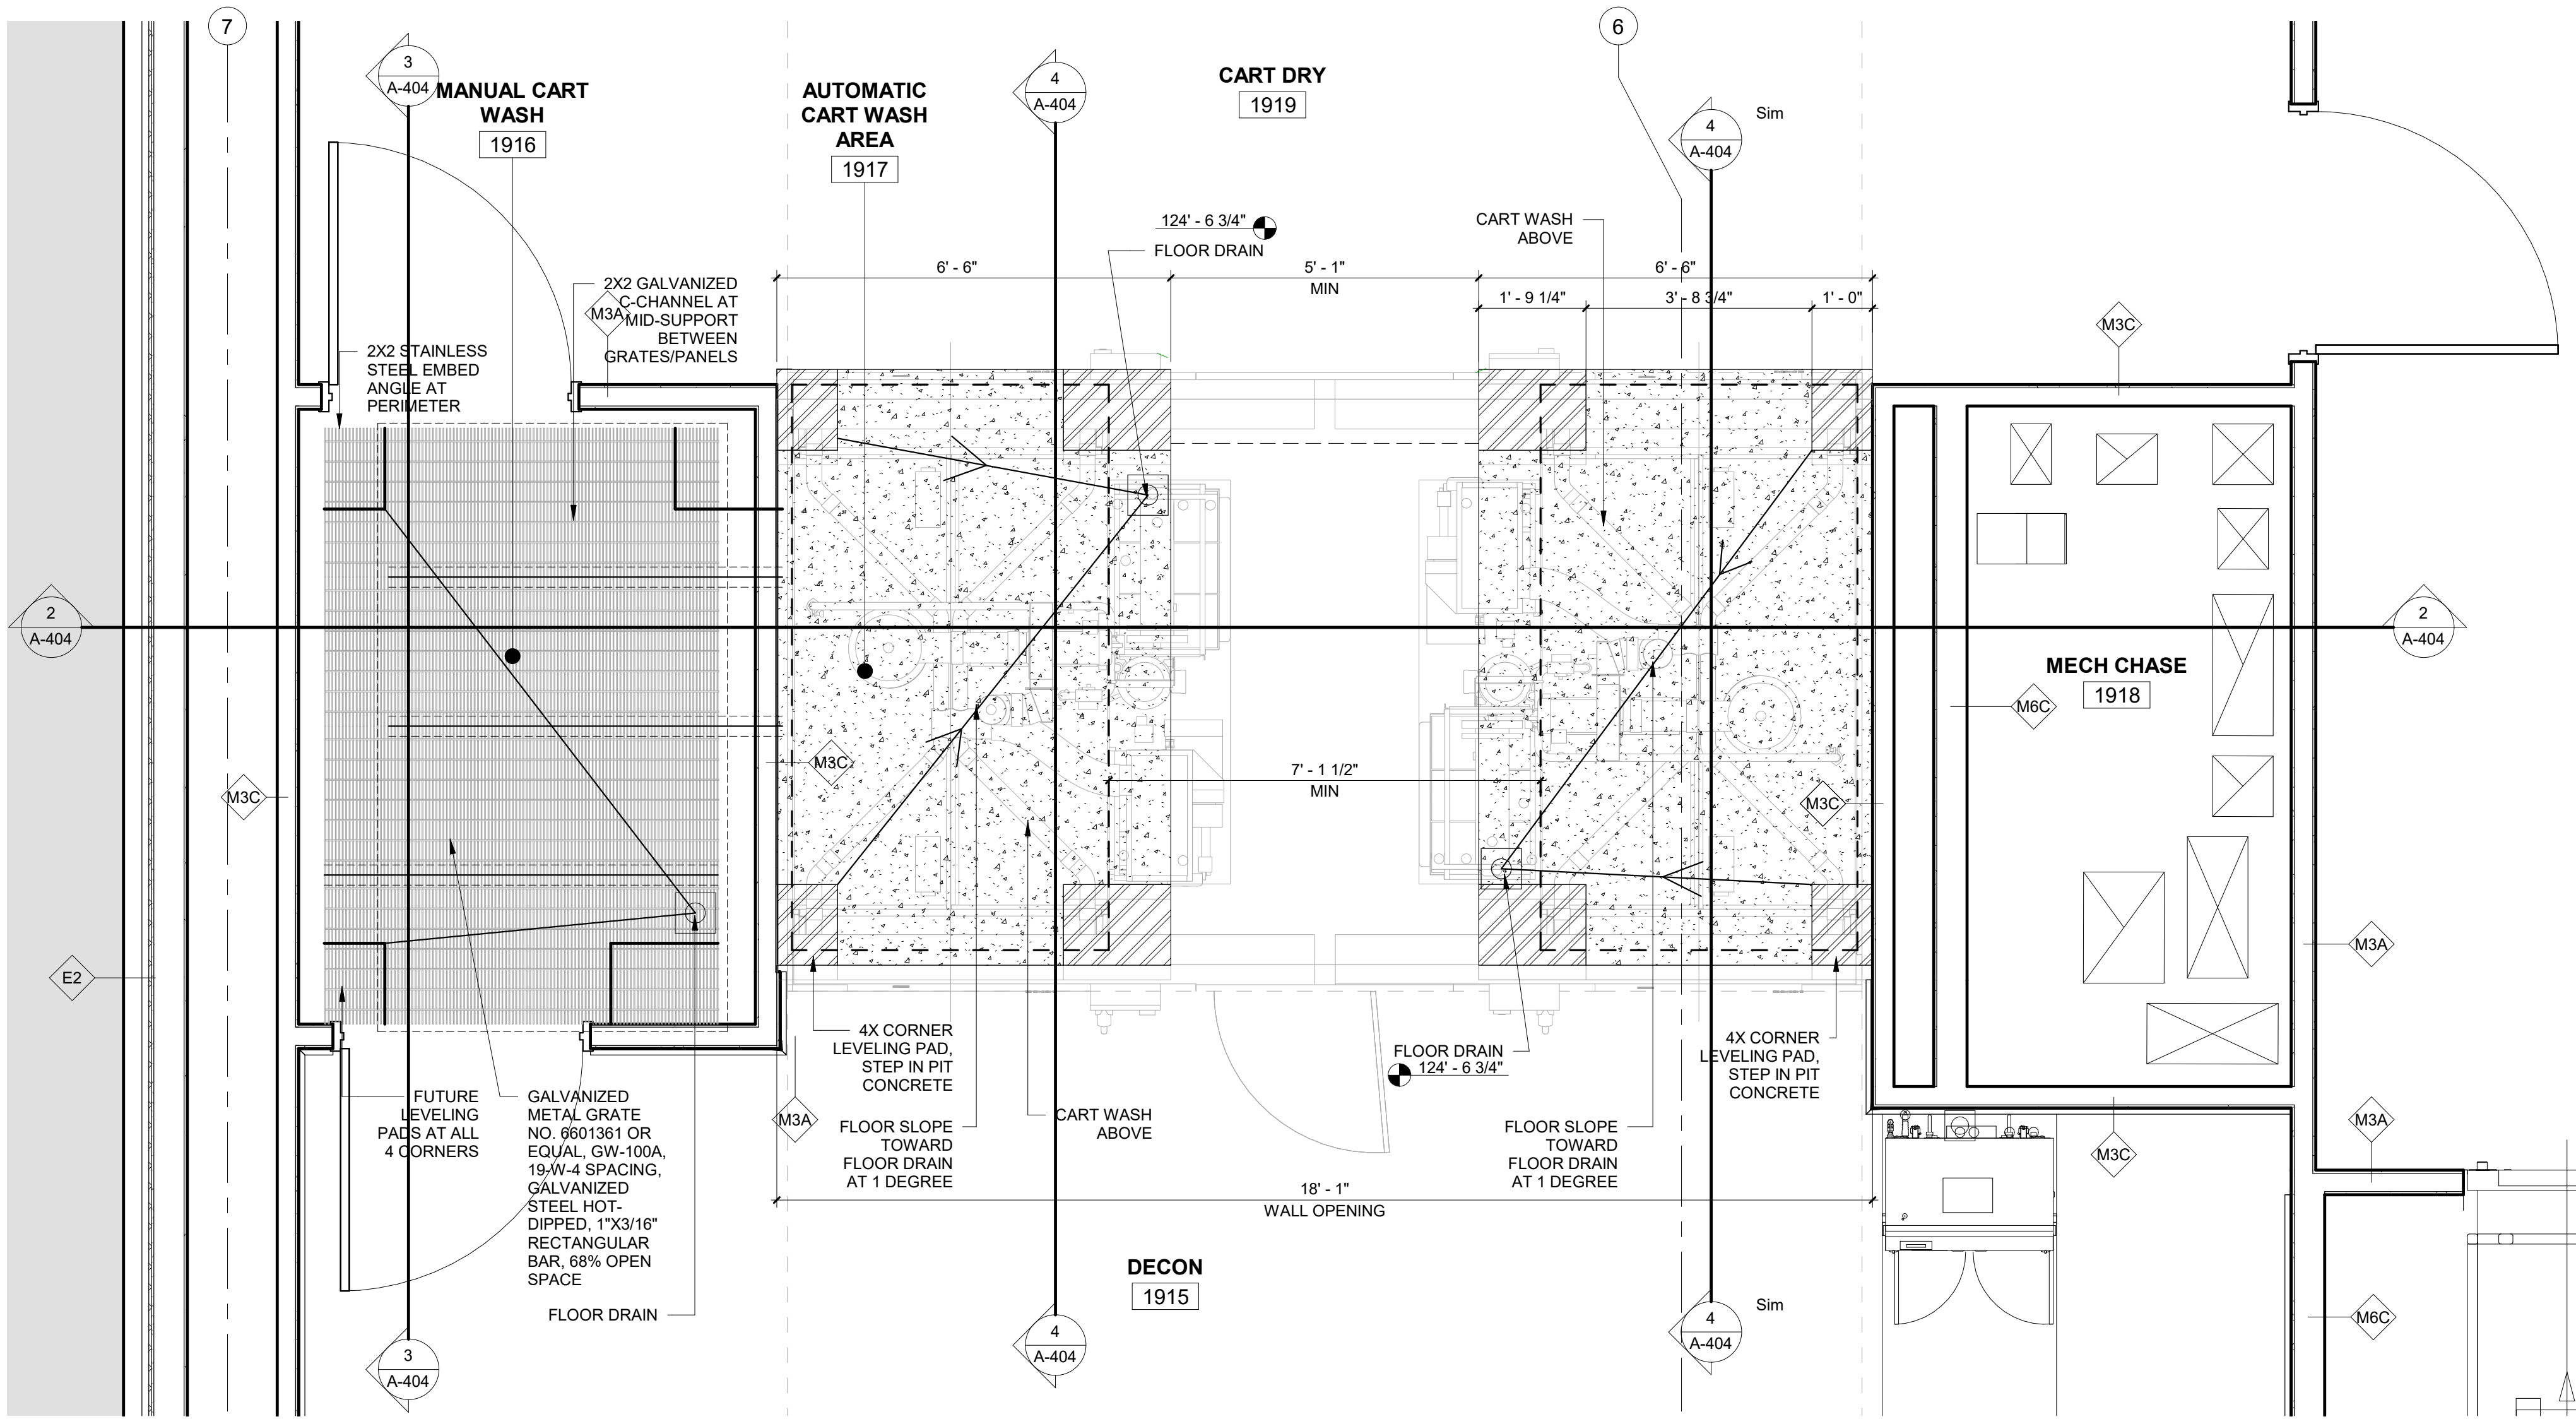


1 ENLARGED PLAN - CART WASH
1/2" = 1'-0"

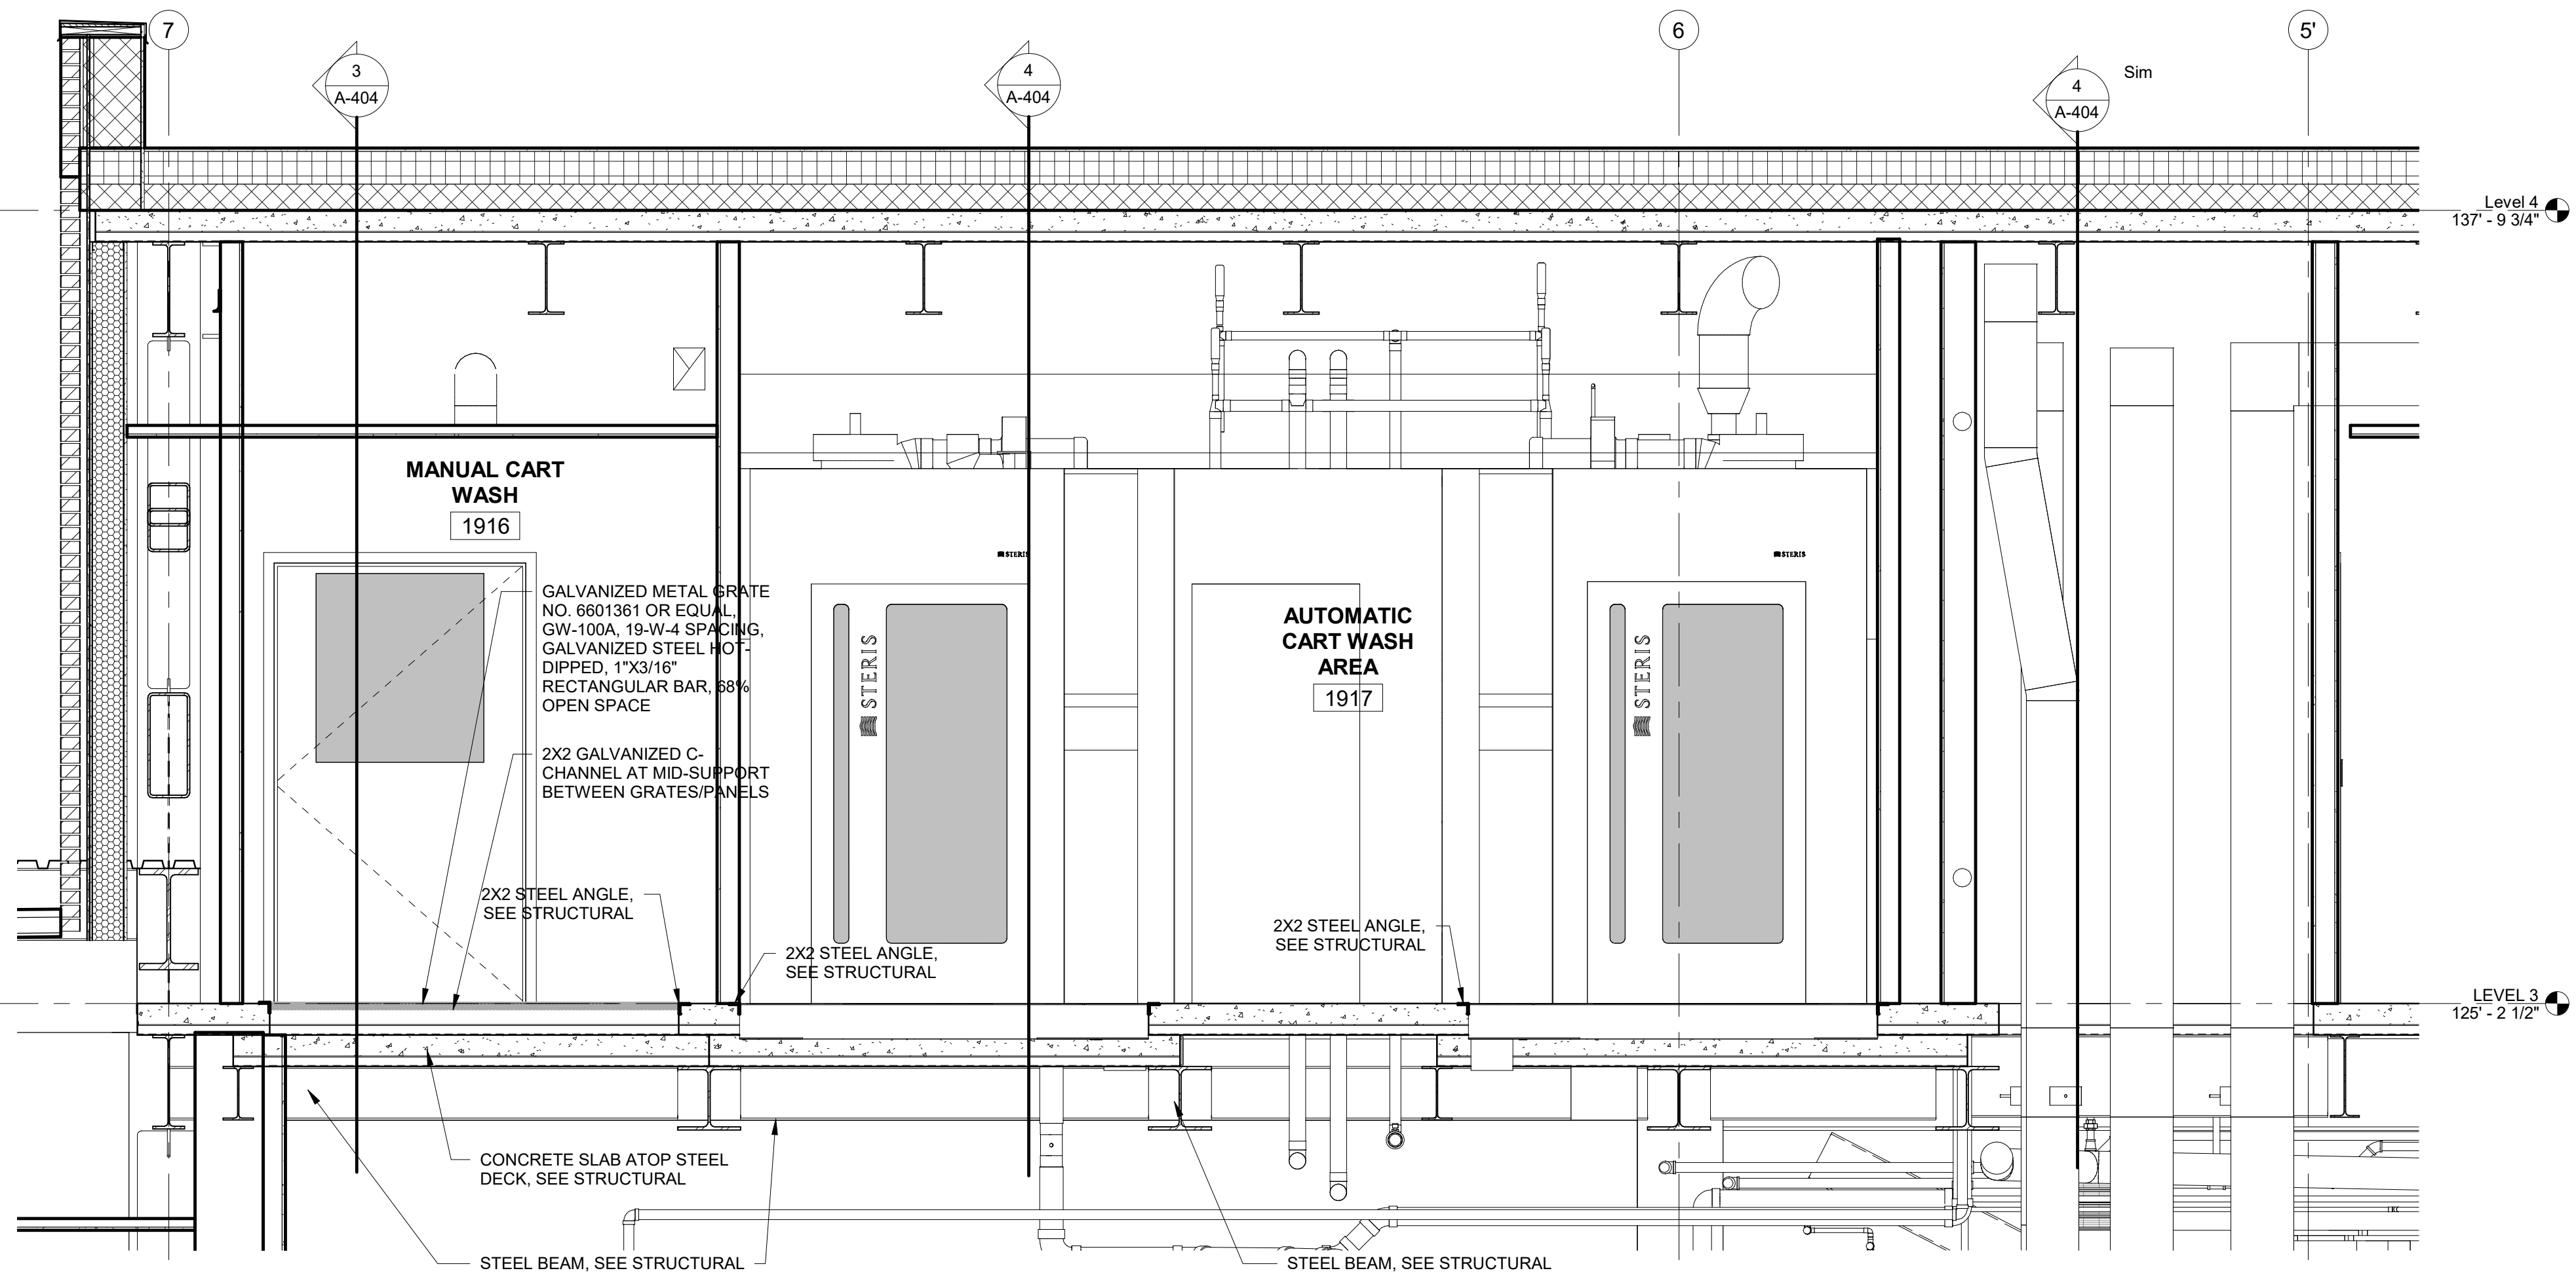


2 CART WASH SECTION
1/2" = 1'-0"

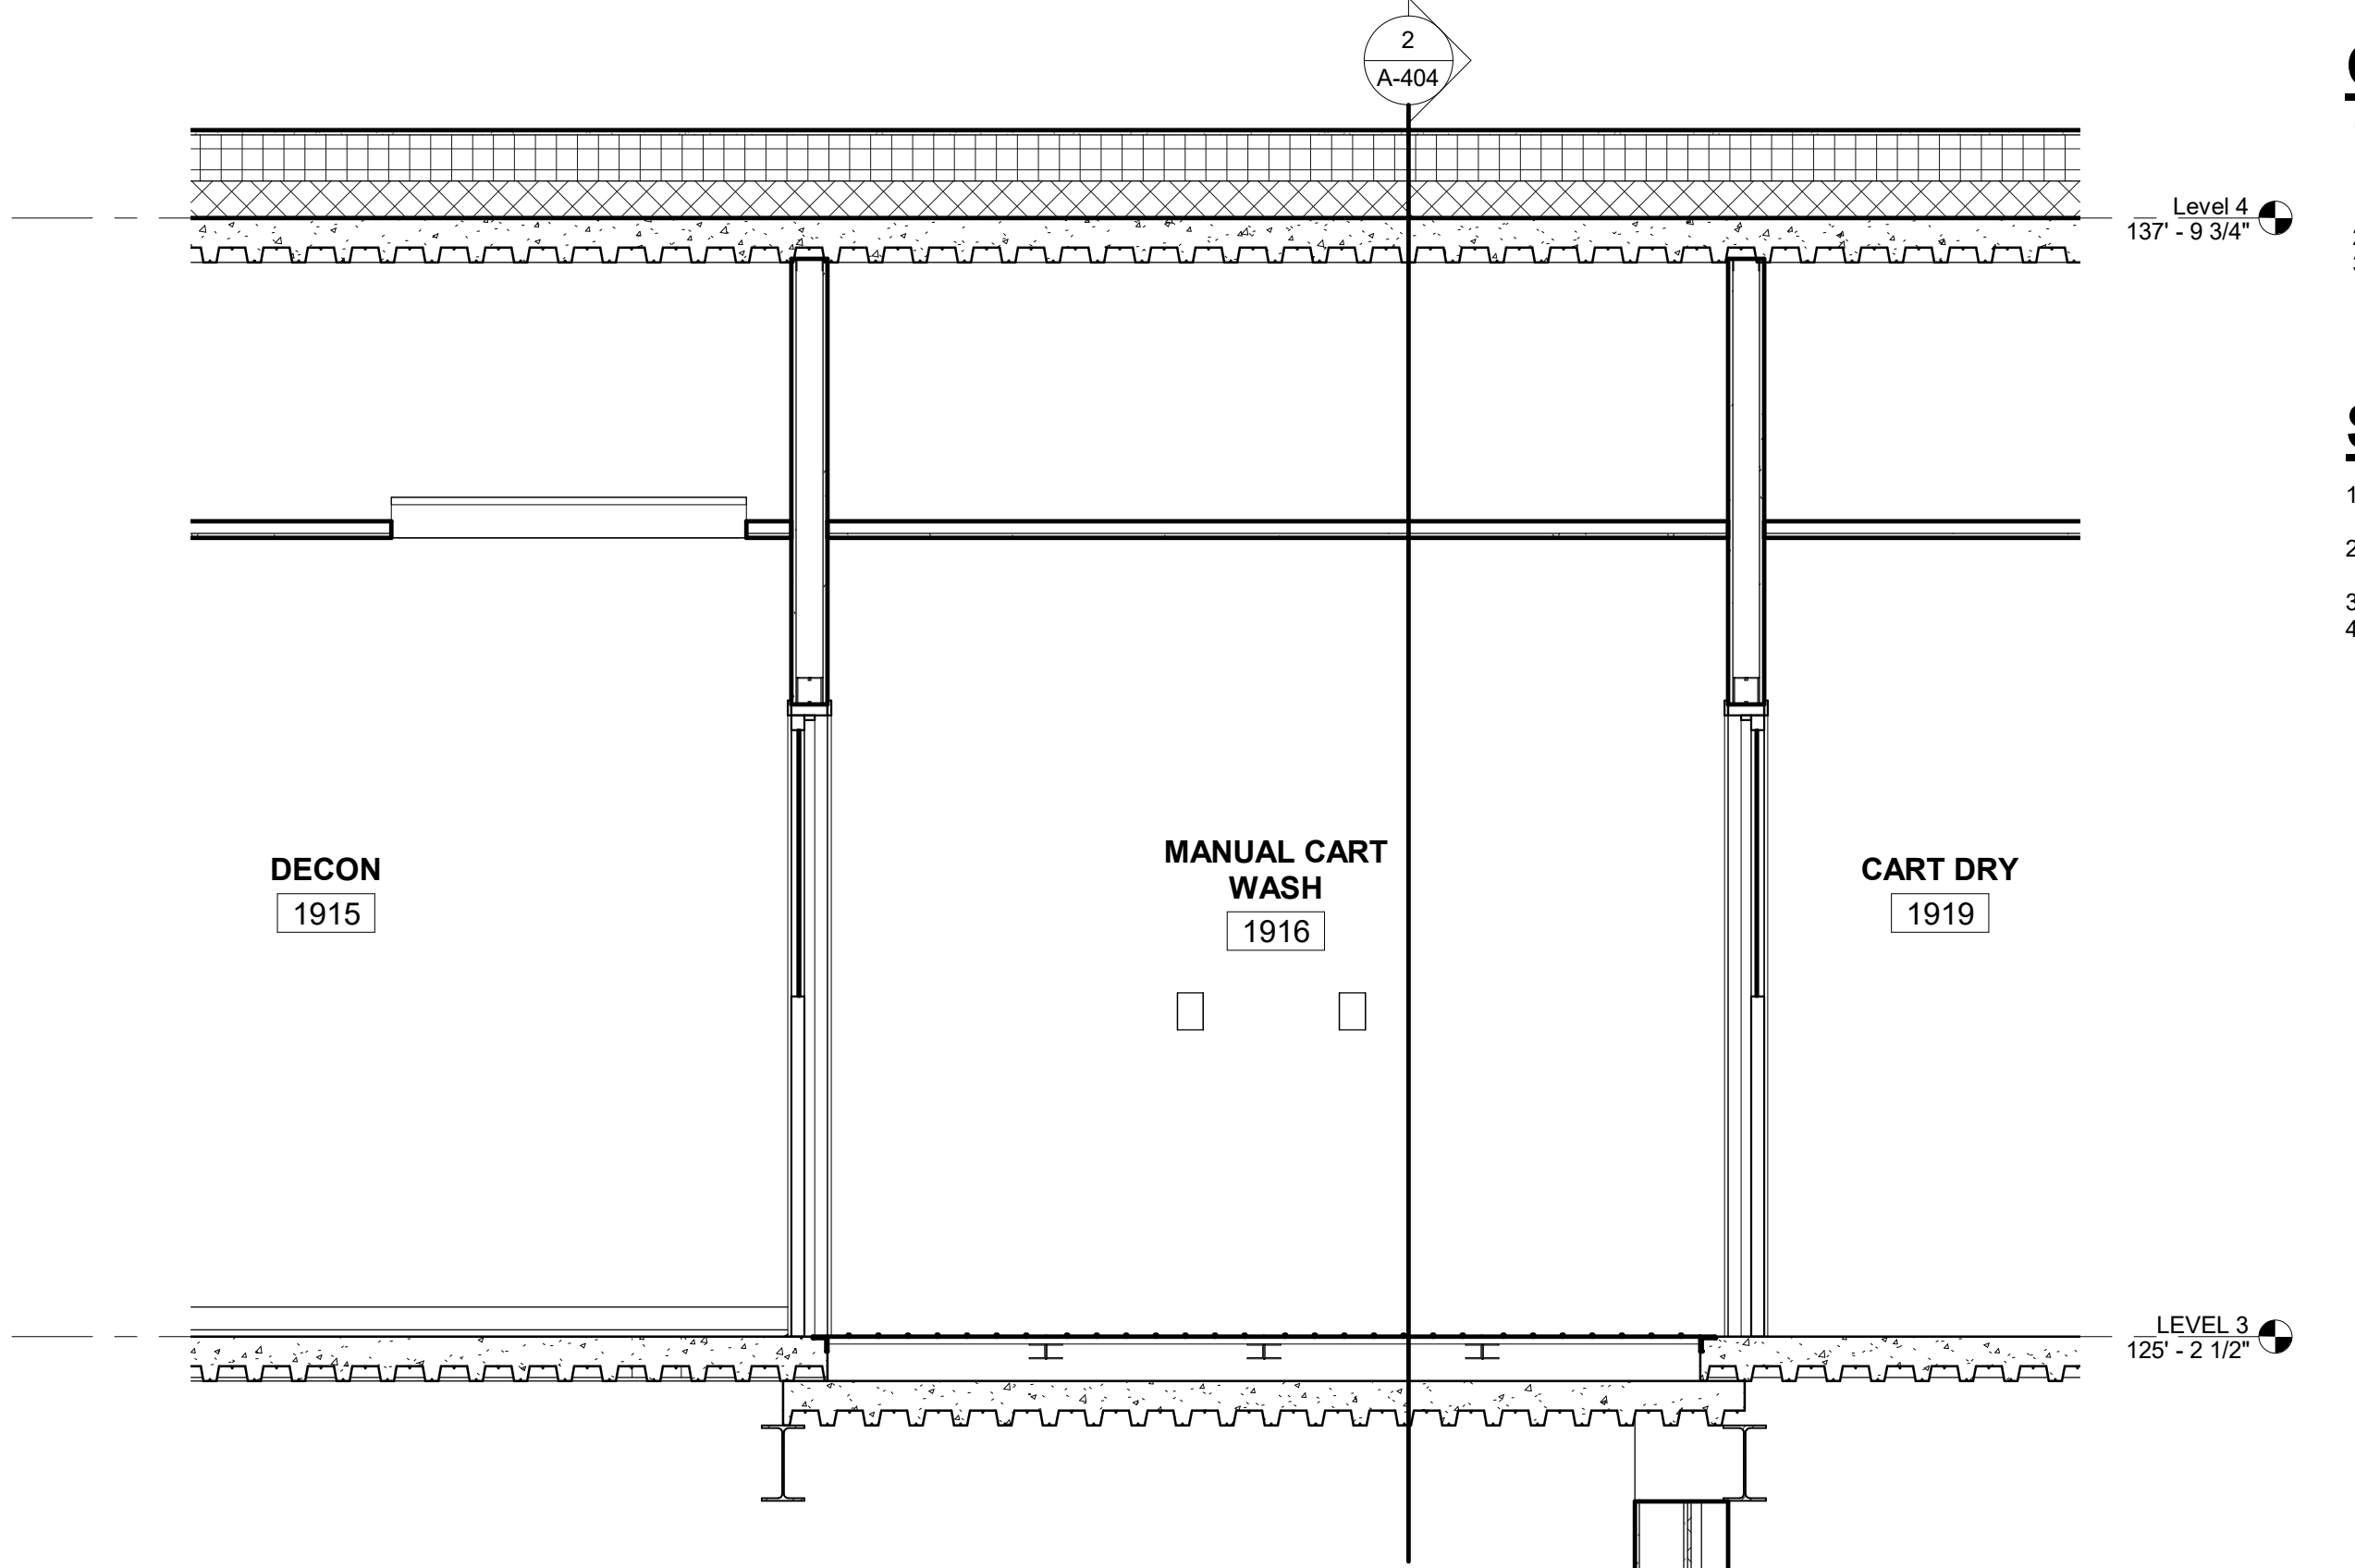

3 SECTION E/W 1916 MANUAL CART WASH
1/2" = 1'-0"

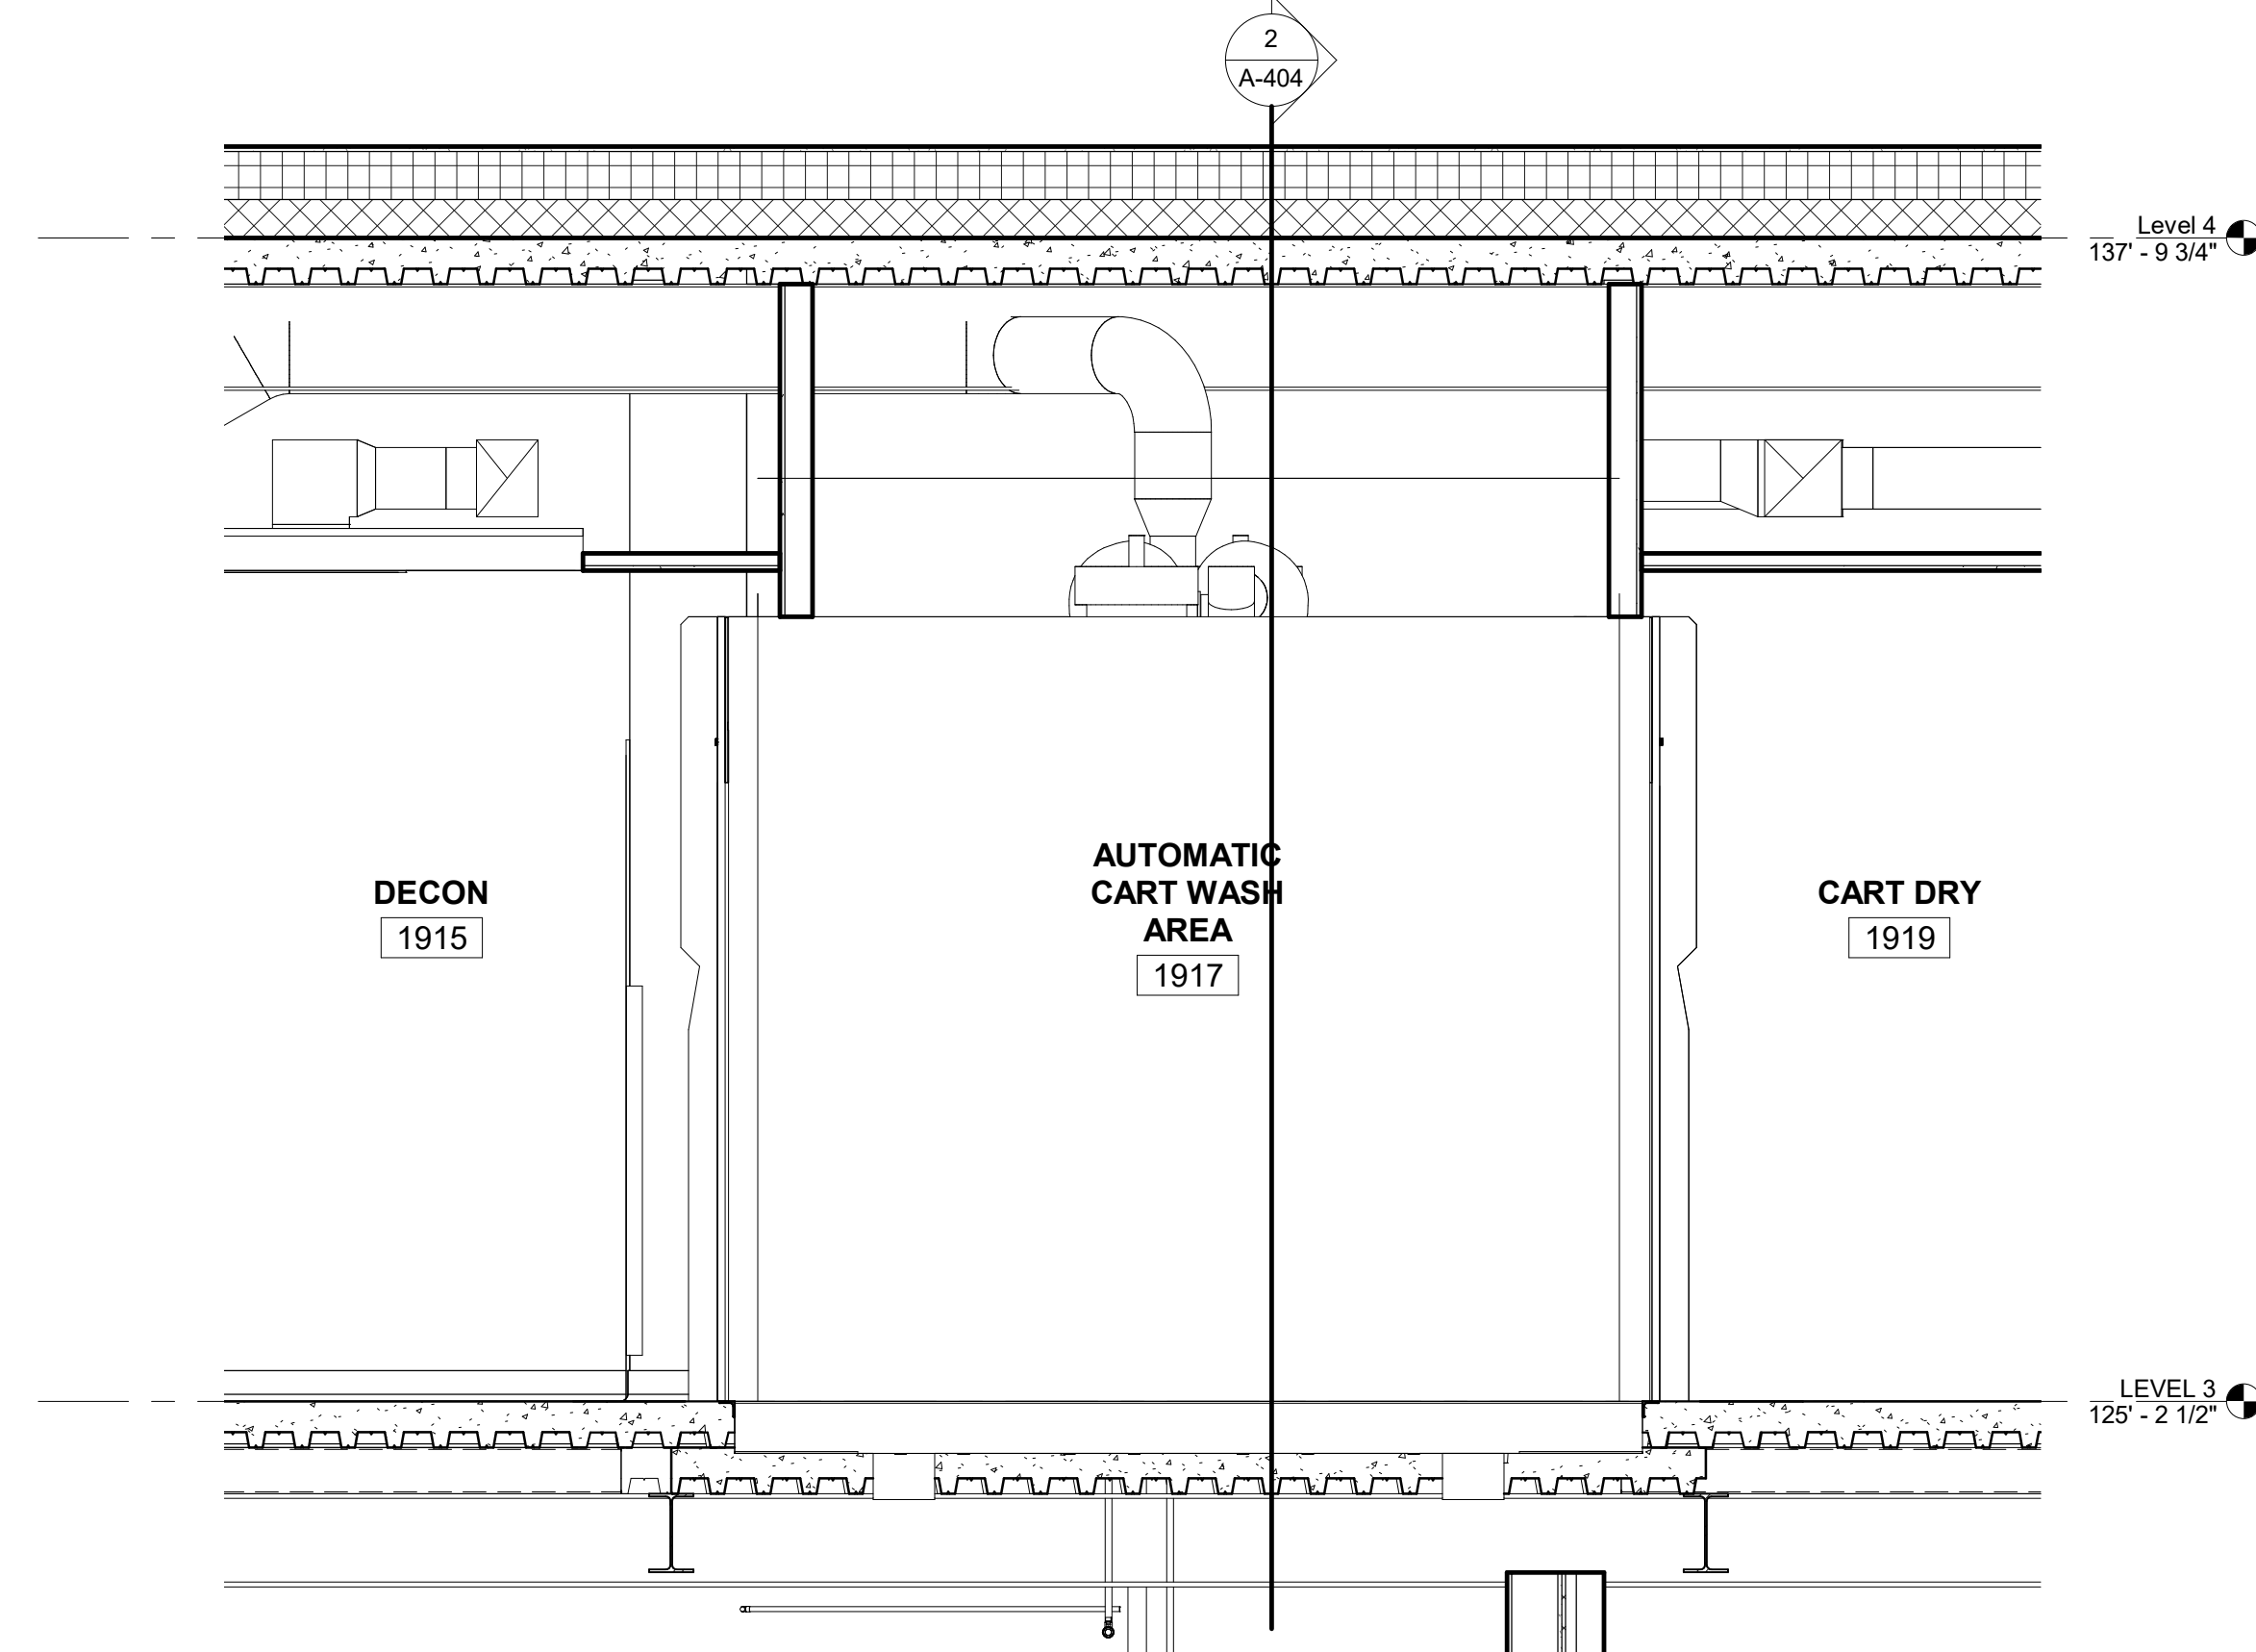

4 SECTION E/W 1917-1918 AUTO CART WASH
1/2" = 1'-0"

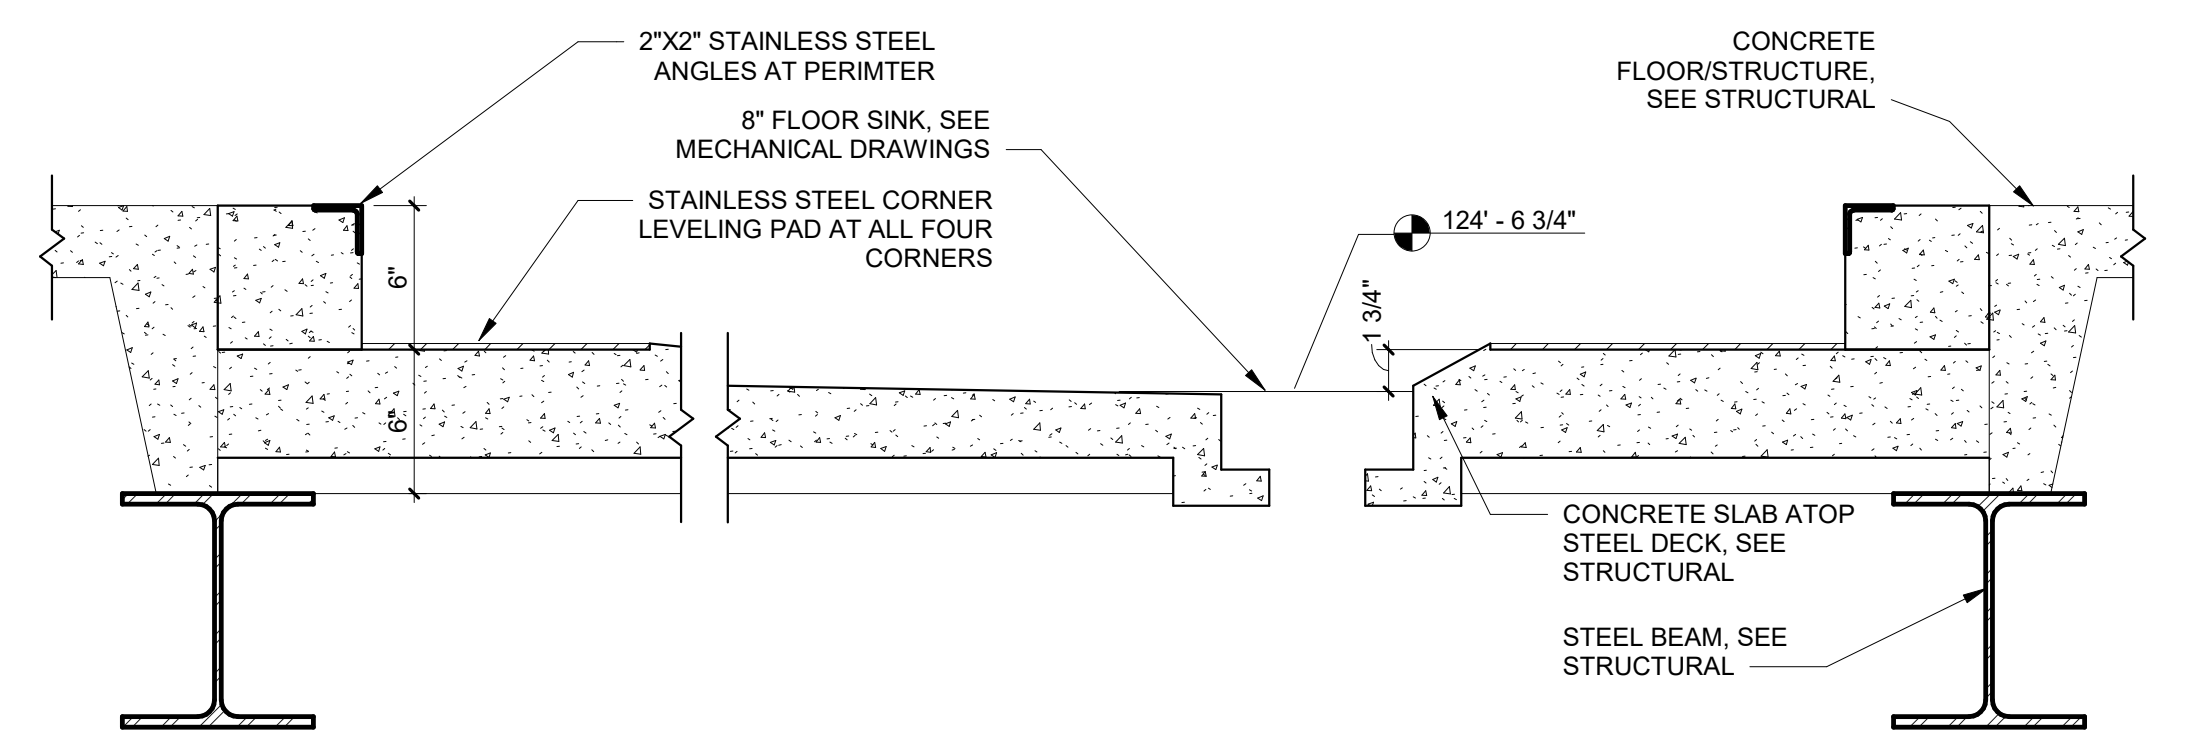

5 DEPRESSED SLAB DETAIL
1 1/2" = 1'-0"

GENERAL NOTES:

1. SHEET SIZE FOR PROPER SCALE IS 30X42. CONTRACTOR SHALL NOT SCALE DRAWINGS BUT SHALL REQUEST THE DESIRED DIMENSIONS FROM THE ARCHITECT.
2. SEE SHEET C-002 FOR GENERAL NOTES.
3. APPLY 1 1/2" THICK FIREPROOFING AT ALL EXPOSED STEEL WITHIN INTERSTITIAL SPACE AND AT EXPOSED STEEL STRUCTURE ABOVE 3RD FLOOR CEILING, TYP.

SHEET SPECIFIC NOTES:

1. ALL CEILING HEIGHTS ARE 9'-0" AFF UNLESS NOTED OTHERWISE.
2. CEILING FIXTURES SHOWN REFERENCE ON REFER TO MECHANICAL / ELECTRICAL DRAWINGS.
3. REFER TO A-000 AND A-101 FOR PARTITION TYPES.
4. REFER TO FLOOR FINISH PLAN ON A-511 FOR FLOORING AT CART WASH AREAS.

CONSTRUCTION DOCUMENTS

COMPLIANCE REVIEW COMPLETED	2/23/2024
Revisions:	Date

CONSULTANTS:

TERRASITE DESIGN
1635 DEADWOOD AVENUE
RAPID CITY, SOUTH DAKOTA 57702
PH: (605) 791-1736

Albertson Engineering Inc.

ALBERTSON ENGINEERING, INC.
315 NORTH MAIN AVENUE, SUITE 200
SIOUX FALLS, SOUTH DAKOTA 57104
PH: (605) 274-0880

FARRIS ENGINEERING
OMAHA (BRANCH) | SENECA | COSSAHO (BRANCH)
FARRIS-ENGINEERING.COM | PH: 1.800.843.1111

FARRIS ENGINEERING
12700 WEST DODGE ROAD
OMAHA, NEBRASKA 68154
PH: (402) 330-5900



ARCHITECT

FOURFRONT DESIGN, INC.
517 7TH STREET
RAPID CITY, SOUTH DAKOTA 57701
PH: (605) 342-9470
FAX: (605) 342-2377
WWW.FOURFRONTDESIGN.COM

Drawing Title
CART WASH DETAILS
Approved: Project Director Omaha VA Medical Center

Project Title
Design/Construct Sterile Processing Service- Omaha VA Medical Center
Location 4101 Woolworth Ave #4199 Omaha, Ne 68105
Date 11/23/2020
Checked JL
Drawn JGC

Project Number
16.2330.A08
Building Number
25
Drawing Number
A-404
Dwg. 49 of 143

Office of
Construction
and Facilities
Management



one and one half inches = one foot
three quarters inch = one foot
one quarter inch = one foot
three eighths inch = one foot
one eighth inch = one foot

ROOM FINISH SCHEDULE									
NUMBER	NAME	FLOOR FINISH	BASE FINISH	WALLS				CEILING FINISH	REMARKS
				NORTH	EAST	SOUTH	WEST		
1802	INTERSTITIAL SPACE	CONC	RB	P1	P1	P1	P1	EXP	
1802A	ELECTRICAL	CONC	RB	P1	P1	P1	P1	EXP	
1802B	ELECTRICAL	CONC	RB	P1	P1	P1	P1	EXP	
1802C	ELECTRICAL	CONC	RB	P1	P1	P1	P1	EXP	
1803	STAIRS	RF	RB	P1A	P1A	P1A	P1A	EXP	
1900	CORRIDOR	LVT1	RB	P1A/RWC	P1A/RWC	P1A/RWC	P1A/RWC	AT1	RWC 4'-0" ABOVE BASE; SEE SHEET A-512
1900A	CORRIDOR	LVT1	RB	P1A/RWC	P1A/RWC	P1A/RWC	P1A/RWC	AT1	RWC 4'-0" ABOVE BASE; SEE SHEET A-512
1900B	CORRIDOR	LVT1	RB	P1A/RWC	P1A/RWC	P1A/RWC	P1A/RWC	AT1	RWC 4'-0" ABOVE BASE; SEE SHEET A-512
1901	OPEN SPACE	LVT1	RB	SC-2	SC-2	SC-2	SC-2	SC-2	
1902	IT	LVT1	RB	P1	P1	P1	P1	EXP	
1902A	MECH. CHASE								
1903	ANTEROOM, SOILED TRANSITION / DROP-OFF	RES-6	RES-6	RES-W1	RES-W1	RES-W1	RES-W1	RES-W1	
1904	SCOPE DROP OFF	RES-6	RES-6	SC1	SC1	SC1	SC1	SC1	
1905	SCOPE PROC	RES-6	RES-6	SC1	SC1	SC1	SC1	SC1	
1906A	SCOPE ANTE	RES-6	RES-6	RES-W1	RES-W1	RES-W1	RES-W1	RES-W1	
1906B	SCOPE STG	RES-6	RES-6	SC1	SC1	SC1	SC1	SC1	
1907	WOMEN'S LOCKER	PT1	PT2	RWC/SC1	RWC/SC1	RWC/SC1	RWC/SC1	AT1	RWC 4'-0" AFF
1907A	WOMEN'S RR	PT1	PT2	PT2/SC1	PT2/SC1	PT2/SC1	PT2/SC1	SC1	
1907B	WOMEN'S RR	PT1	PT2	PT2/SC1	PT2/SC1	PT2/SC1	PT2/SC1	SC1	
1907C	WOMEN'S SHOWER	PT3	PT2	PT2/SC1	PT2/SC1	PT2/SC1	PT2/SC1	SOFFIT - SC1	
1908	MEN'S LOCKER	PT1	PT2	RWC/SC1	RWC/SC1	RWC/SC1	RWC/SC1	SOFFIT - AT1	RWC 4'-0" AFF
1908A	MEN'S RR	PT1	PT2	PT2/SC1	PT2/SC1	PT2/SC1	PT2/SC1	SC1	
1908B	MEN'S RR	PT1	PT2	PT2/SC1	PT2/SC1	PT2/SC1	PT2/SC1	SC1	
1908C	MEN'S SHOWER	PT3	PT2	PT2/SC1	PT2/SC1	PT2/SC1	PT2/SC1	SC1	
1909	BREAK ROOM	LVT1	RB	-	P1/RWC	P4	P1/RWC	AT1	
1910	OPEN OFFICE/TRAINING	LVT1	RB	P1/RWC	P1/RWC	-	P1/RWC	AT1	
1911	ANTE VENDOR DROP OFF	RES-6	RES-6	RES-W1	RES-W1	RES-W1	RES-W1	RES-W1	
1912	H2O	RES-6	RES-6	SC1	SC1	SC1	SC1	SC1	
1913	CART PASS	RES-6	RES-6	RWC/RES-W1	RWC/RES-W1	RWC/RES-W1	RWC/RES-W1	RES-W1	RWC 8'-0" AFF
1913A	MECH. CHASE								
1914	HAC	RES-6	RES-6	RWC/SC1	RWC/SC1	RWC/SC1	RWC/SC1	SC1	RWC 4' - 0" AFF WAINSCOT
1915	DECON	RES-6	RES-6	SC1	SC1	SC1	SC1	SC1	
1916	MANUAL CART WASH	RES-6	RES-6	PT2	PT2	PT2	PT2	SC1	
1917	AUTOMATIC CART WASH AREA	RES-6	RES-6					SC1	
1918	MECH CHASE								
1919	CART DRY	RES-6	RES-6	PT2/RES-W1	PT2/RES-W1	PT2/RES-W1	PT2/RES-W1	RES-W1	PT2 AT 6'-0" ABOVE BASE
1920	STERILIZATION	RES-6	RES-6	RES-W1	RES-W1	RES-W1	RES-W1	RES-W1	
1921	STERILE STG	RES-6	RES-6	SC1/RWC	SC1/RWC	SC1/RWC	SC1/RWC	SC1	RWC 8' - 0" AFF
1921A	MECH. CHASE								
1923	PREP ASSEMBLY	RES-6	RES-6	SC1	SC1	SC1	SC1	SC1	
1924	ANTE	RES-6	RES-6	RES-W1	RES-W1	RES-W1	RES-W1	RES-W1	
1925	HAC	RES-6	RES-6	RWC/SC1	RWC/SC1	RWC/SC1	RWC/SC1	RWC	RWC 4' - 0" AFF WAINSCOT
1926	CONFERENCE	CPT1	RB	P3	P1	P1	P1	AT1	
1927	OPEN OFFICE	CPT1	RB	P3	P1	P1	P1	AT1	
1928	OFFICE	CPT1	RB	P3	P1	P1	P1	AT1	
1929	OFFICE	CPT1	RB	P3	P1	P1	P1	AT1	
1930	COPIER ROOM	LVT1	RB	P1	P1	P1	P1	AT1	
1931	STAIRS	RF	RB	P1A	P1A	P1A	P1A	EXP	
1932	CORRIDOR								

ROOM FINISH SCHEDULE LEGEND:

MATERIAL DESCRIPTION:

AT ACOUSTIC CEILING TILE
CONC CONCRETE, SEALED
CPT CARPET TILE
EPV EPOXY COATED CONCRETE
EXP EXPOSED
GWB GYPSUM WALL BOARD
P-1A SCUFFMASTER PAINT
P1 PAINT 1
P2 PAINT 2
P3 PAINT 3
PT-1 PORCELAIN TILE 1
PT-2 PORCELAIN TILE 2
PT-3 PORCELAIN TILE 3
RB RUBBER BASE
RES-W RESINOUS WALL COATING
RES-6 RESINOUS FLOORING LEVEL 6A
RF RUBBER FLOORING - STAIR SYSTEM
RWC RIGID WALL PROTECTION PANEL
SC-1 SPECIALTY COATING
SC-2 SPECIALTY COATING (UV)


TOILET ACCESSORY SCHEDULE	
A	42" GRAB BAR
B	18" GRAB BAR
C	TOILET PAPER DISPENSER
D	36" GRAB BAR

GENERAL NOTES:


- SHEET SIZE FOR PROPER SCALE IS 30X42. CONTRACTOR SHALL NOT SCALE DRAWINGS BUT SHALL REQUEST THE DESIRED DIMENSIONS FROM THE ARCHITECT.
- SEE SHEET G-002 FOR GENERAL NOTES.
- APPLY 1 1/2" THICK FIREPROOFING AT ALL EXPOSED STEEL WITHIN INTERSTITIAL SPACE AND AT EXPOSED STEEL STRUCTURE ABOVE 3RD FLOOR CEILING, TYP.

SHEET SPECIFIC NOTES:

- SEE WALL PROTECTION PLAN FOR SPECIFIC LOCATIONS OF WALL PANELS, CORNER GUARDS, BUMPER RAILS AND HANDRAILS.
- PORCELAIN TILE, SOLID SURFACING, RESINOUS WALL APPLICATION OVER CONCRETE BACKER BOARD. SEE SPECIFICATIONS.
- COORDINATE SHOWER STALL AND FLOOR LAYOUTS BASED ON DIMENSIONS OF SHOWER FLOOR MANUFACTURER'S ROUGH-IN REQUIREMENTS.

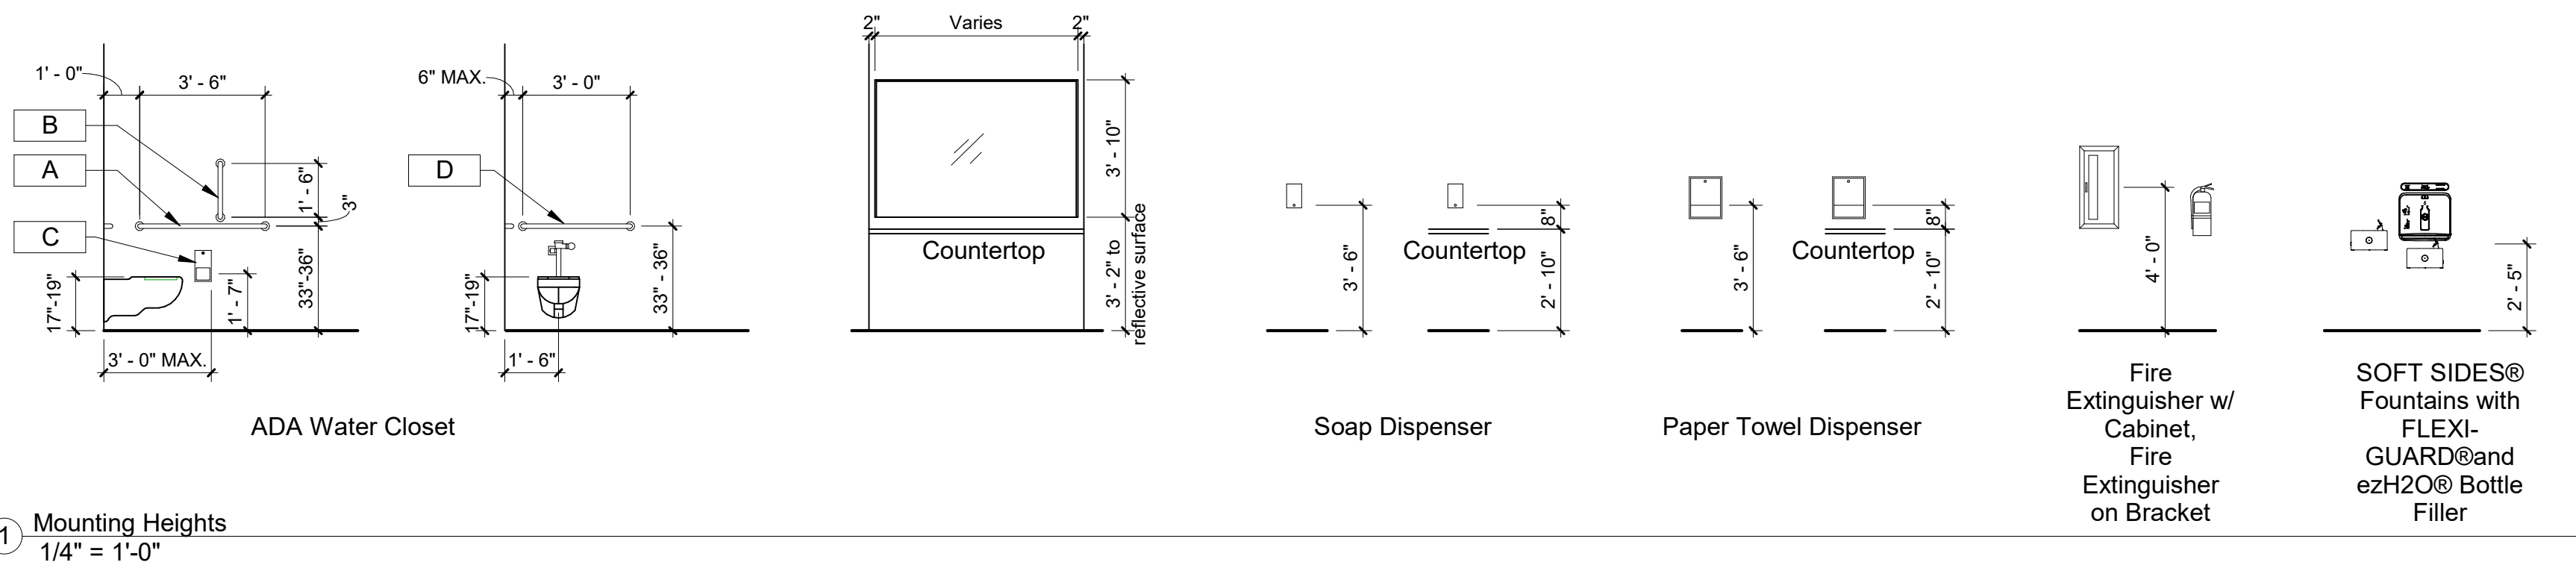


1 Mounting Heights
1/4" = 1'-0"

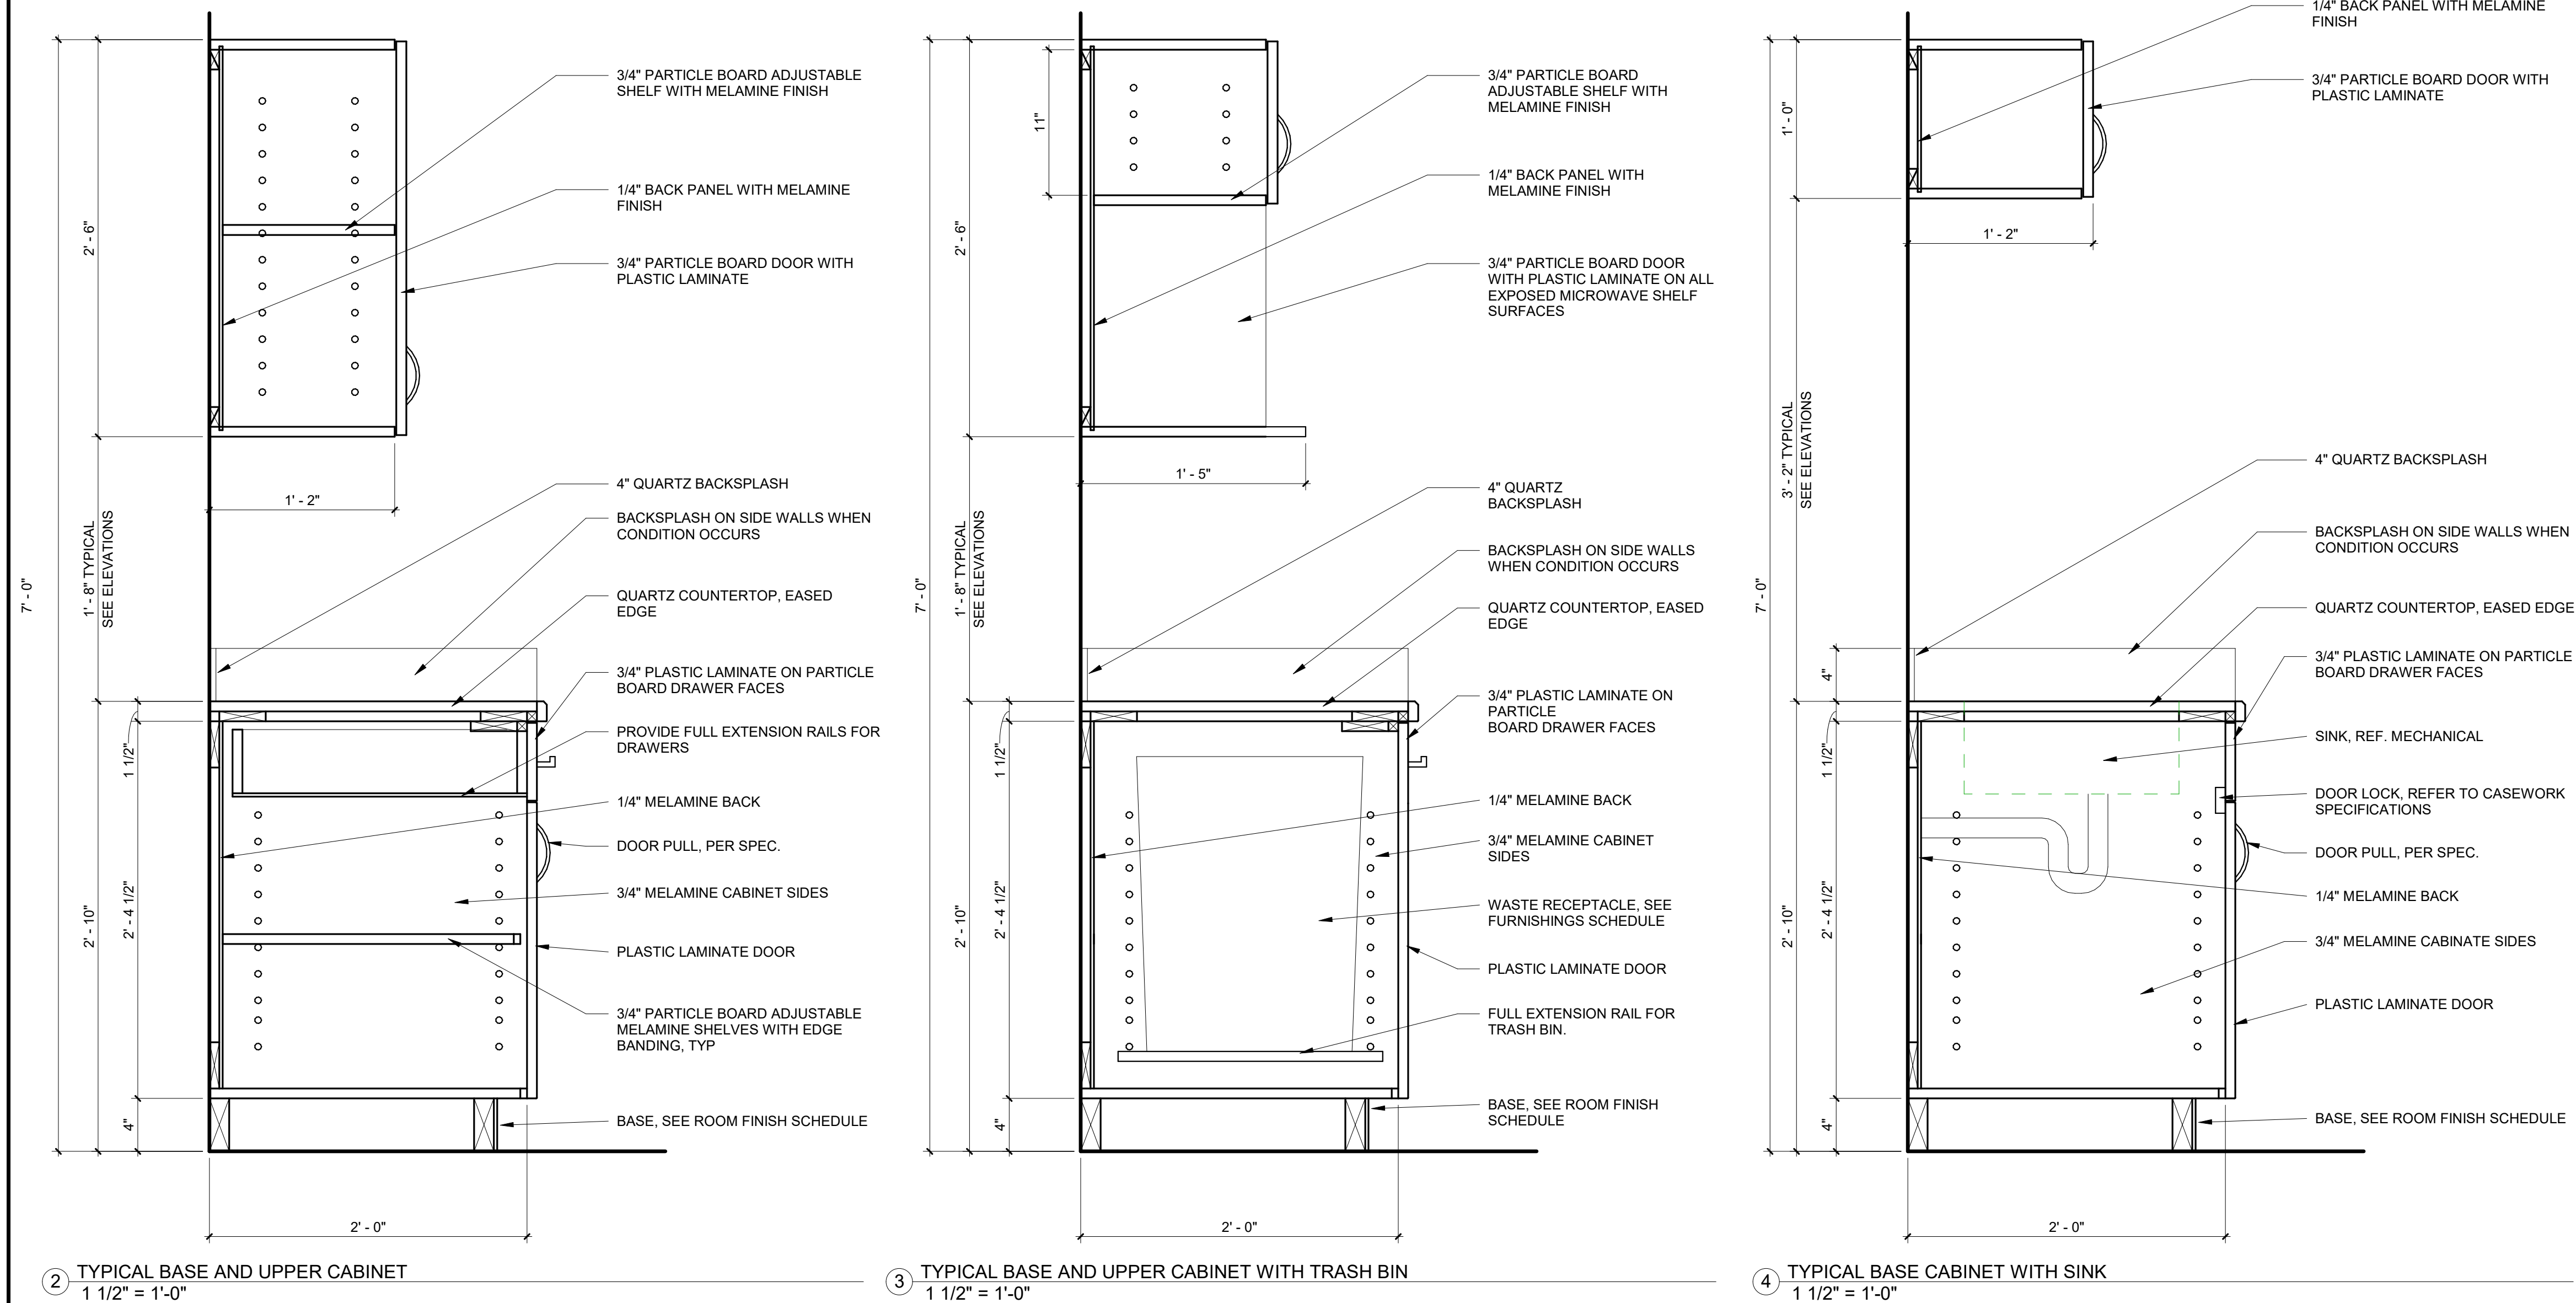

2 TYPICAL BASE AND UPPER CABINET
1 1/2" = 1'-0"

3 TYPICAL BASE AND UPPER CABINET WITH TRASH BIN
1 1/2" = 1'-0"

4 TYPICAL BASE CABINET WITH SINK
1 1/2" = 1'-0"

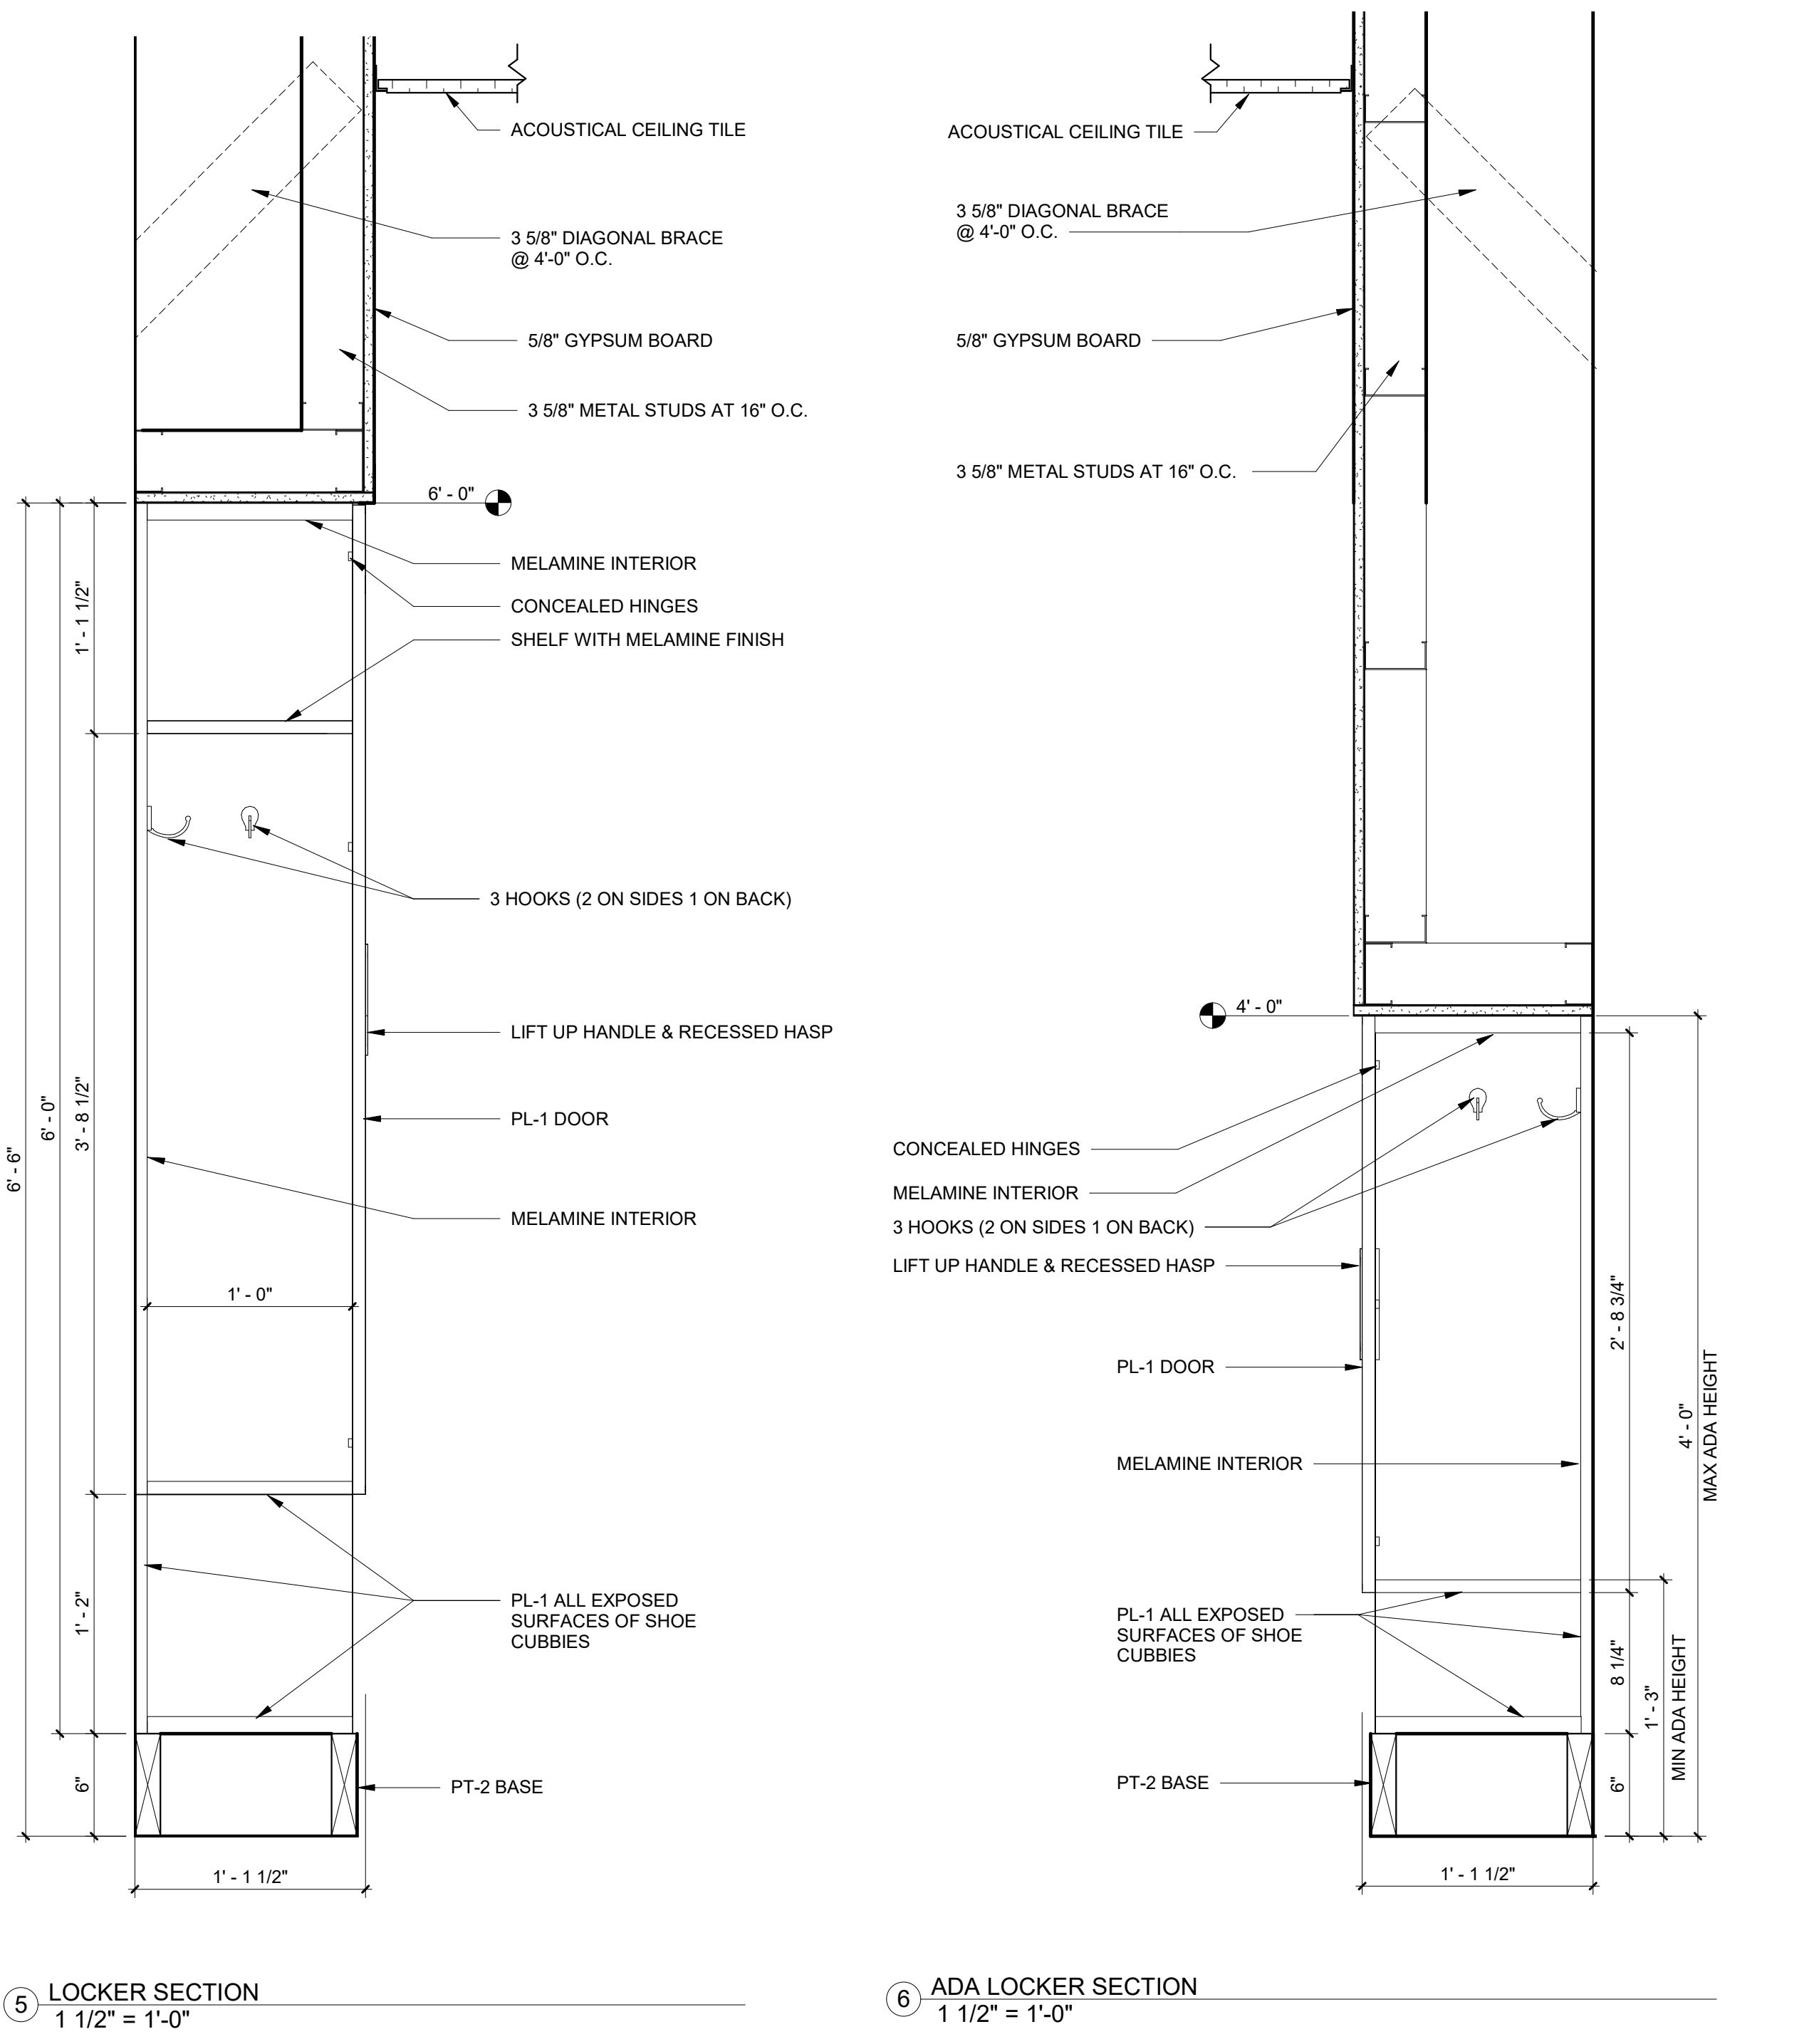

5 LOCKER SECTION
1 1/2" = 1'-0"

6 ADA LOCKER SECTION
1 1/2" = 1'-0"

COMPLIANCE REVIEW COMPLETED

Revisions:

2/23/2024

Date

CONSULTANTS:

TERRASITE DESIGN
1635 DEADWOOD AVENUE
RAPID CITY, SOUTH DAKOTA 57702
PH: (605) 791-1736

Albertson Engineering Inc.

FARRIS ENGINEERING
OMAHA (BRICKS) 30101 COLUMBUS DRIVE
OMAHA, NEBRASKA 68154
PH: (402) 330-5900

ALBERTSON ENGINEERING, INC.
315 NORTH MAIN AVENUE, SUITE 200
SIOUX FALLS, SOUTH DAKOTA 57104
PH: (605) 274-0880

ARCHITECT

FOURFRONT DESIGN, INC.
517 7TH STREET
RAPID CITY, SOUTH DAKOTA 57701
PH: (605) 342-9470
FAX: (605) 342-2377
WWW.FOURFRONTDESIGN.COM

Drawing Title

ROOM FINISH SCHEDULE

Approved: Project Director

Omaha VA Medical Center

Project Title

Design/Construct Sterile Processing Service- Omaha VA Medical Center

Location

4101 Woolworth Ave #4199 Omaha, Ne 68105

Date

11/23/2020

Checked

JL

Drawn

JGC

Project Number

16.2330.A08

Building Number

25

Drawing Number

A-500

Dwg. 50 of 143

Office of Construction and Facilities Management

Department of Veterans Affairs


VA FORM 08-6231

GENERAL NOTES:


1. SHEET SIZE FOR PROPER SCALE IS 30X42. CONTRACTOR SHALL NOT SCALE DRAWINGS BUT SHALL REQUEST THE DESIRED DIMENSIONS FROM THE ARCHITECT.
2. SEE SHEET G-002 FOR GENERAL NOTES.
3. APPLY 1 1/2" THICK FIREPROOFING AT ALL EXPOSED STEEL WITHIN INTERSTITIAL SPACE AND AT EXPOSED STEEL STRUCTURE ABOVE 3RD FLOOR CEILING, TYP.

FLOOR FINISH LEGEND:

- EPOXY COATED CONCRETE
- RF - RUBBER FLOORING
- LVT1 - LUXURY VINYL TILE
- RES-6 - RESINOUS FLOORING
- PT1 - PORCELAIN TILE
- PT3 - PORCELAIN TILE
- CPT-1 - CARPET TILE

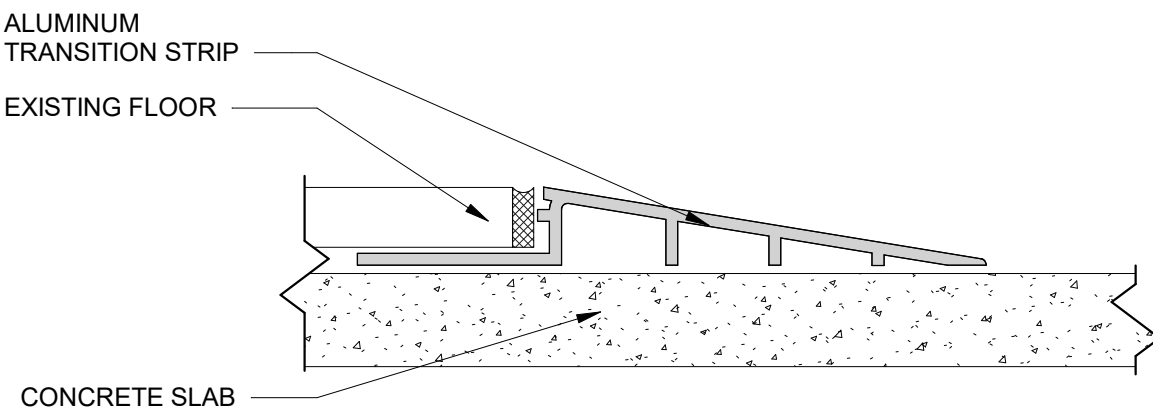


2. TILE/LVT TO RESINOUS FLOORING
12" = 1'-0"

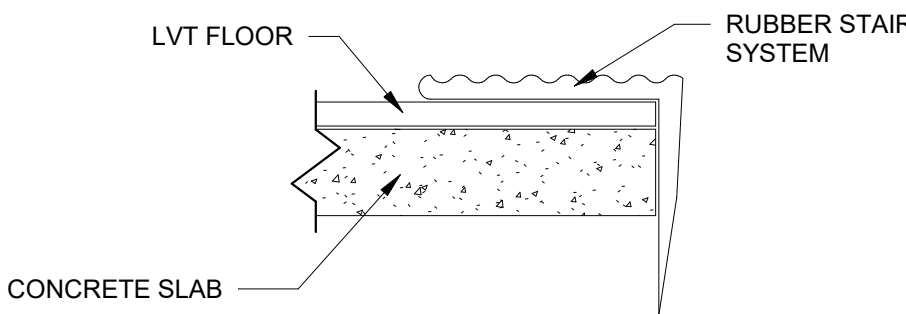

3. RUBBER STAIR SYSTEM TO LVT
12" = 1'-0"

1. FLOOR FINISH PLAN - 2ND LEVEL
1/8" = 1'-0"

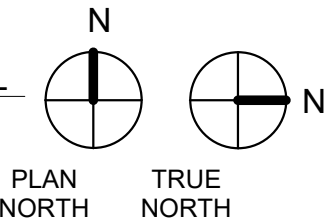

CONSTRUCTION DOCUMENTS

COMPLIANCY REVIEW COMPLETED 2/23/2024 Revisions: Date		CONSULTANTS: TerraSite Design 1635 DEADWOOD AVENUE RAPID CITY, SOUTH DAKOTA 57702 PH: (605) 791-1736 Albertson Engineering Inc. ALBERTSON ENGINEERING, INC. 315 NORTH MAIN AVENUE, SUITE 200 SIOUX FALLS, SOUTH DAKOTA 57104 PH: (605) 274-0880 FARRIS ENGINEERING FARRIS ENGINEERING 12700 WEST DODGE ROAD OMAHA, NEBRASKA 68154 PH: (402) 330-5900		ARCHITECT FOURFRONT DESIGN, INC. 517 7TH STREET RAPID CITY, SOUTH DAKOTA 57701 PH: (605) 342-9470 FAX: (605) 342-2377 WWW.FOURFRONTDESIGN.COM		Drawing Title FLOOR FINISH PLAN - 2ND LEVEL Approved: Project Director Omaha VA Medical Center		Project Title Design/Construct Sterile Processing Service- Omaha VA Medical Center Location 4101 Woolworth Ave #4199 Omaha, Ne 68105 Date 11/23/2020 Checked JL Drawn JGC		Project Number 16.2330.A08 Building Number 25 Drawing Number A-510 Dwg. 51 of 143		Office of Construction and Facilities Management Department of Veterans Affairs	
---	--	--	--	--	--	--	--	---	--	--	--	---	--

6/11/2025 5:13:17 PM

one eighth inch = one foot
one quarter inch = one foot
three eighths inch = one foot
one half inch = one foot
three quarters inch = one foot
one and one half inches = one foot
one and one half inches = one foot
one and one half inches = one foot

one eighth inch = one foot
one quarter inch = one foot
three eighths inch = one foot
one half inch = one foot
three quarters inch = one foot
one and one half inches = one foot
one and one half inches = one foot
one and one half inches = one foot

one eighth inch = one foot
one quarter inch = one foot
three eighths inch = one foot
one half inch = one foot
three quarters inch = one foot
one and one half inches = one foot
one and one half inches = one foot
one and one half inches = one foot


one eighth inch = one foot
one quarter inch = one foot
three eighths inch = one foot
one half inch = one foot
three quarters inch = one foot
one and one half inches = one foot
one and one half inches = one foot
one and one half inches = one foot

one eighth inch = one foot
one quarter inch = one foot
three eighths inch = one foot
one half inch = one foot
three quarters inch = one foot
one and one half inches = one foot
one and one half inches = one foot
one and one half inches = one foot


one eighth inch = one foot
one quarter inch = one foot
three eighths inch = one foot
one half inch = one foot
three quarters inch = one foot
one and one half inches = one foot
one and one half inches = one foot
one and one half inches = one foot

one eighth inch = one foot
one quarter inch = one foot
three eighths inch = one foot
one half inch = one foot
three quarters inch = one foot
one and one half inches = one foot
one and one half inches = one foot
one and one half inches = one foot


one eighth inch = one foot
one quarter inch = one foot
three eighths inch = one foot
one half inch = one foot
three quarters inch = one foot
one and one half inches = one foot
one and one half inches = one foot
one and one half inches = one foot

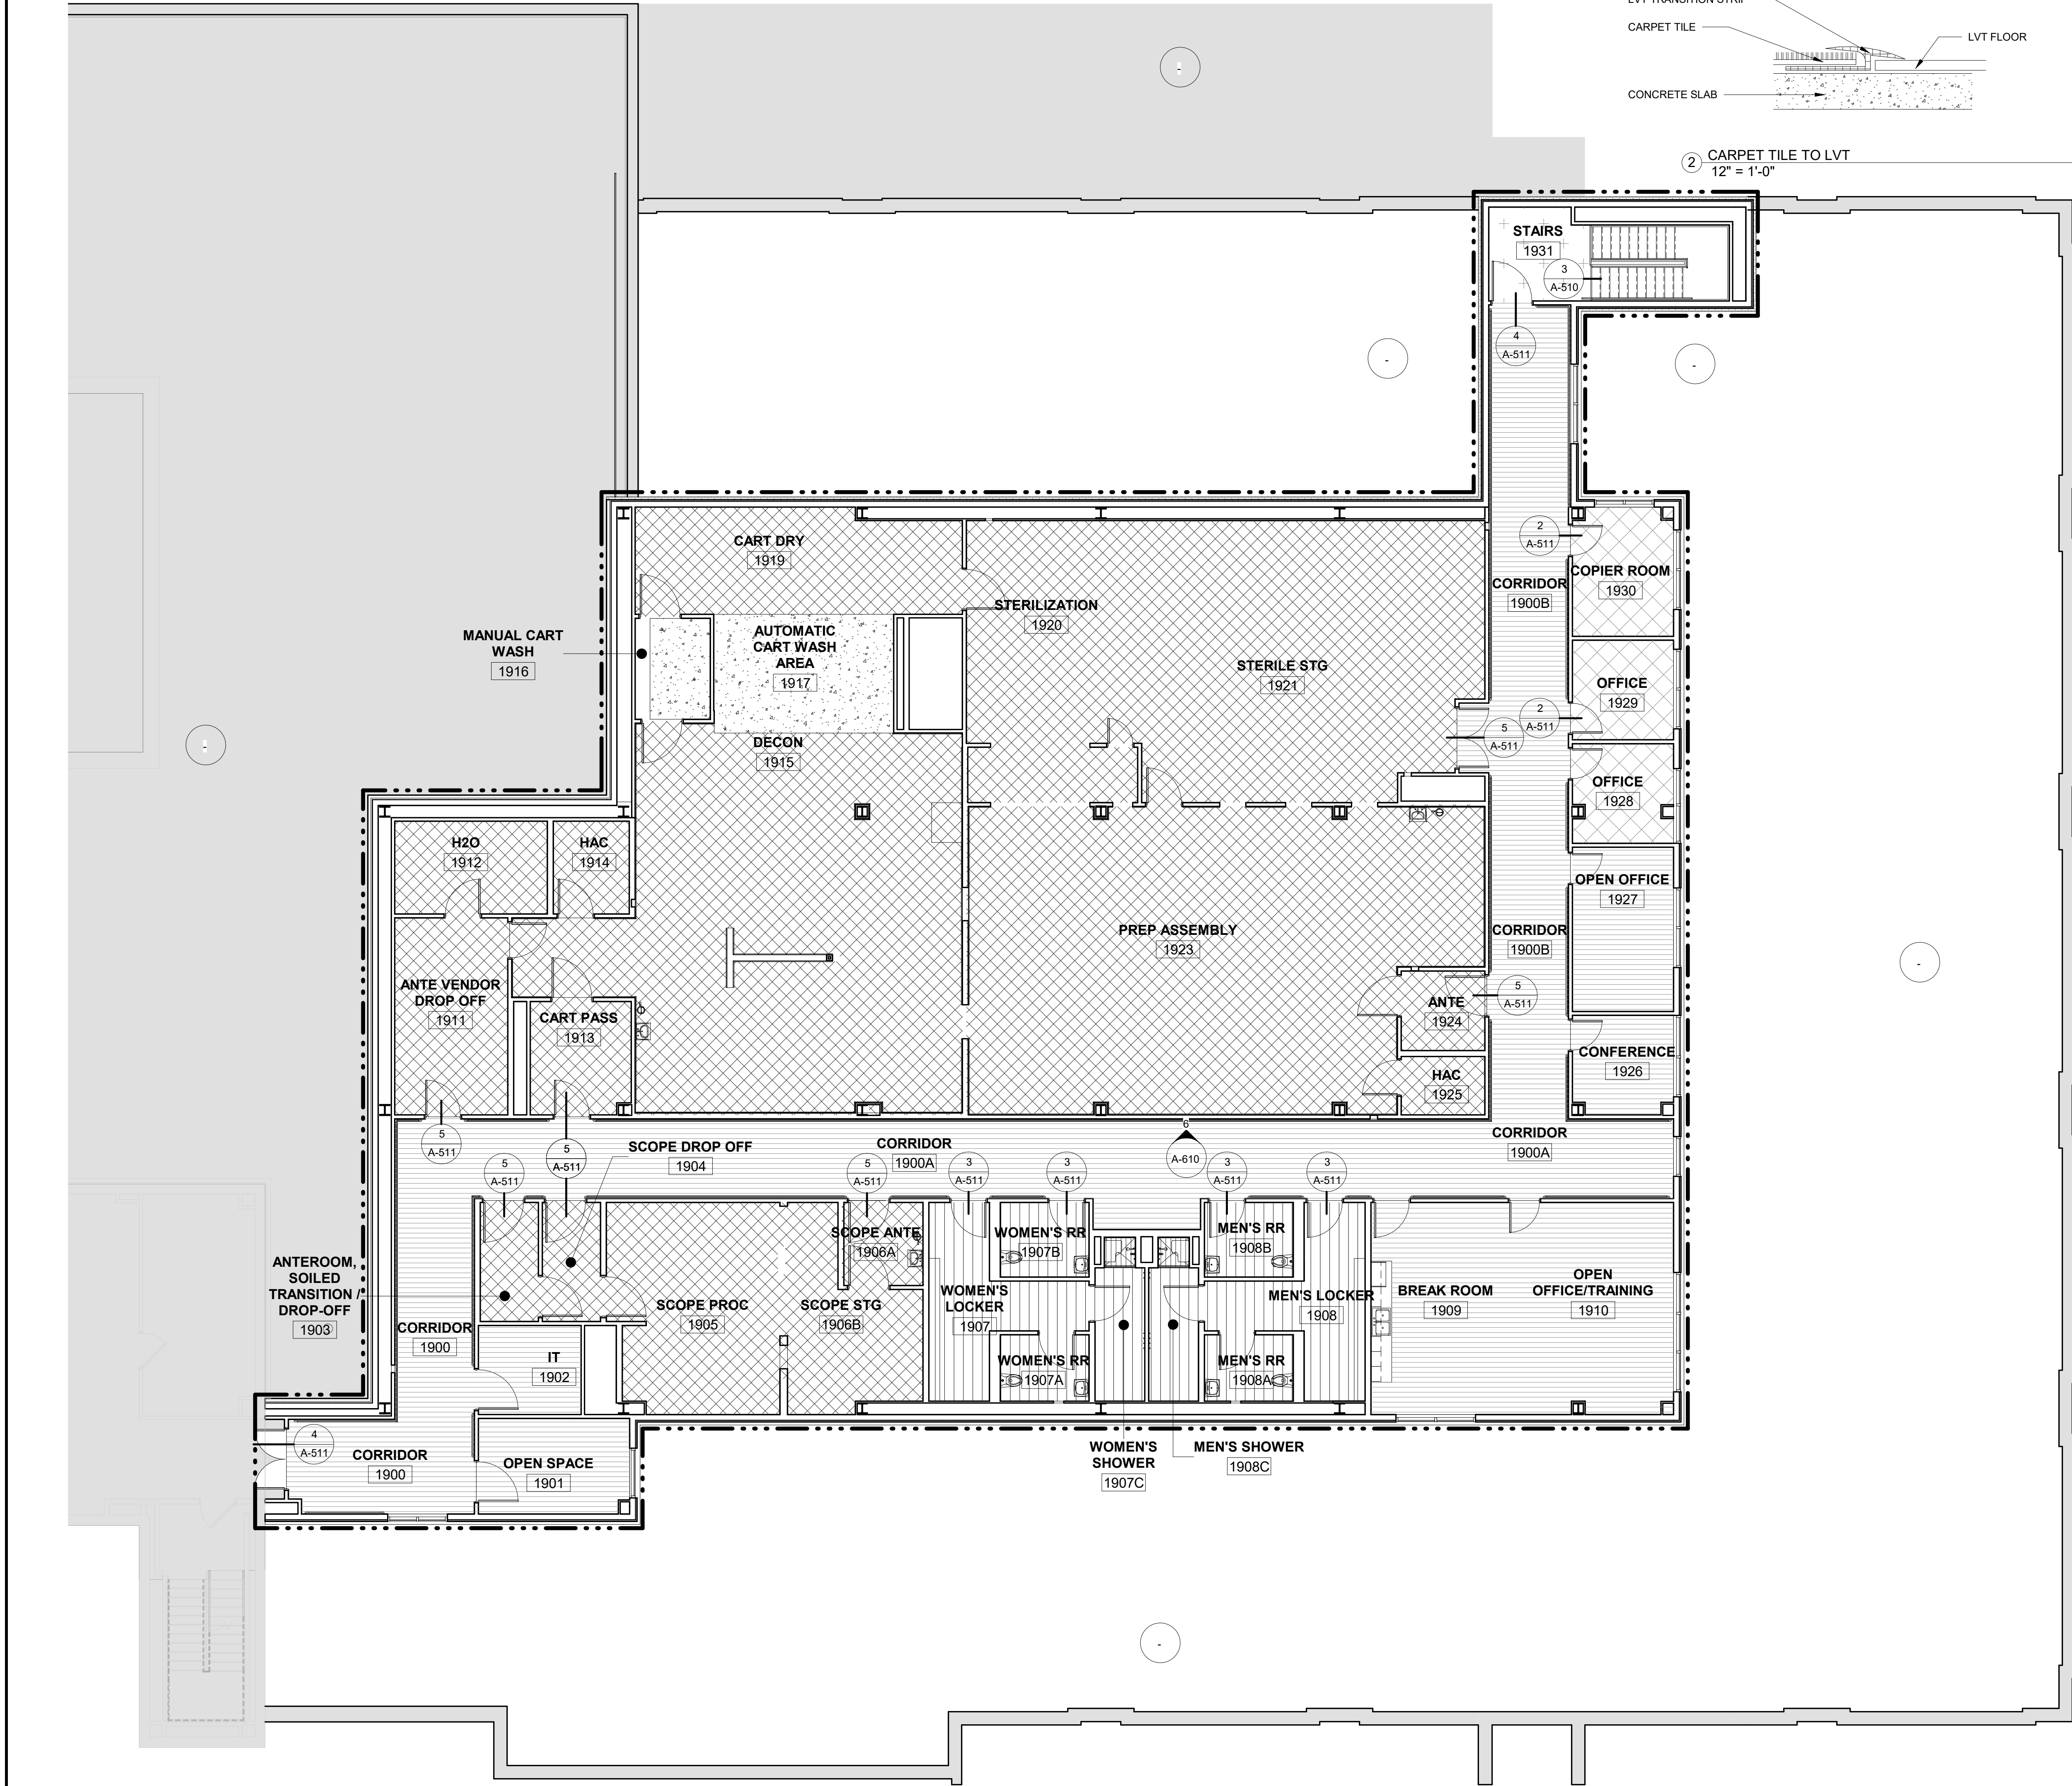


1 FLOOR FINISH PLAN - 3RD LEVEL
1/8" = 1'-0"

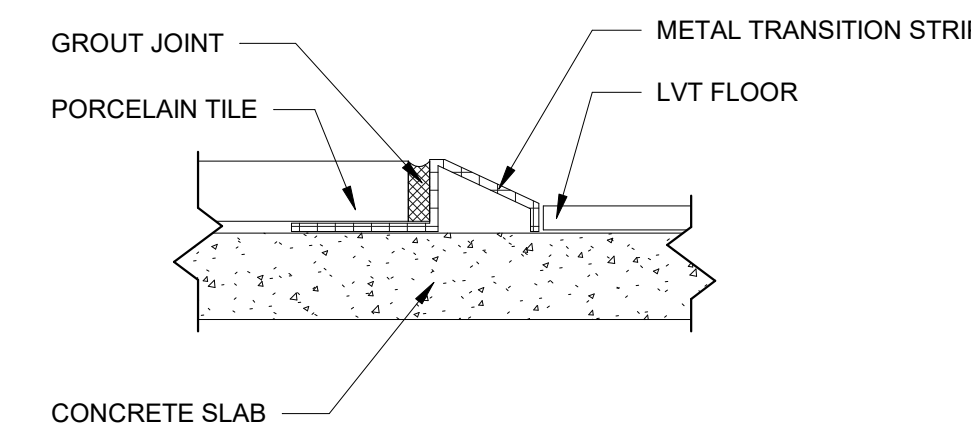


3 PORCELAIN TILE TO LVT
12" = 1'-0"

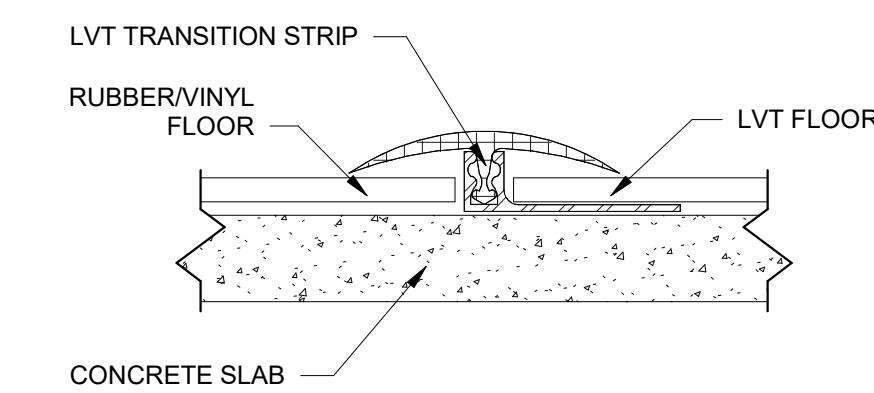


4 RUBBER FLOORING TO LVT
12" = 1'-0"

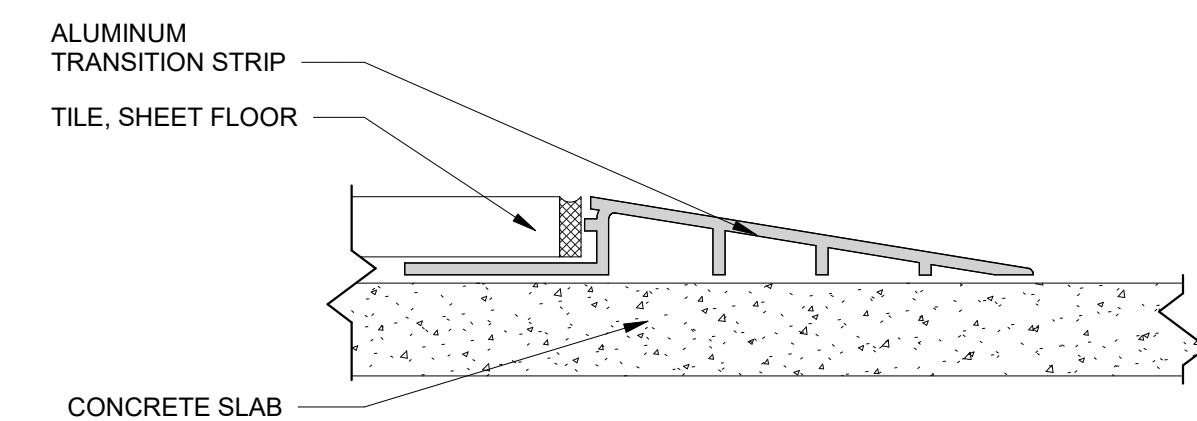


5 TILE/LVT TO RESINOUS FLOORING
12" = 1'-0"

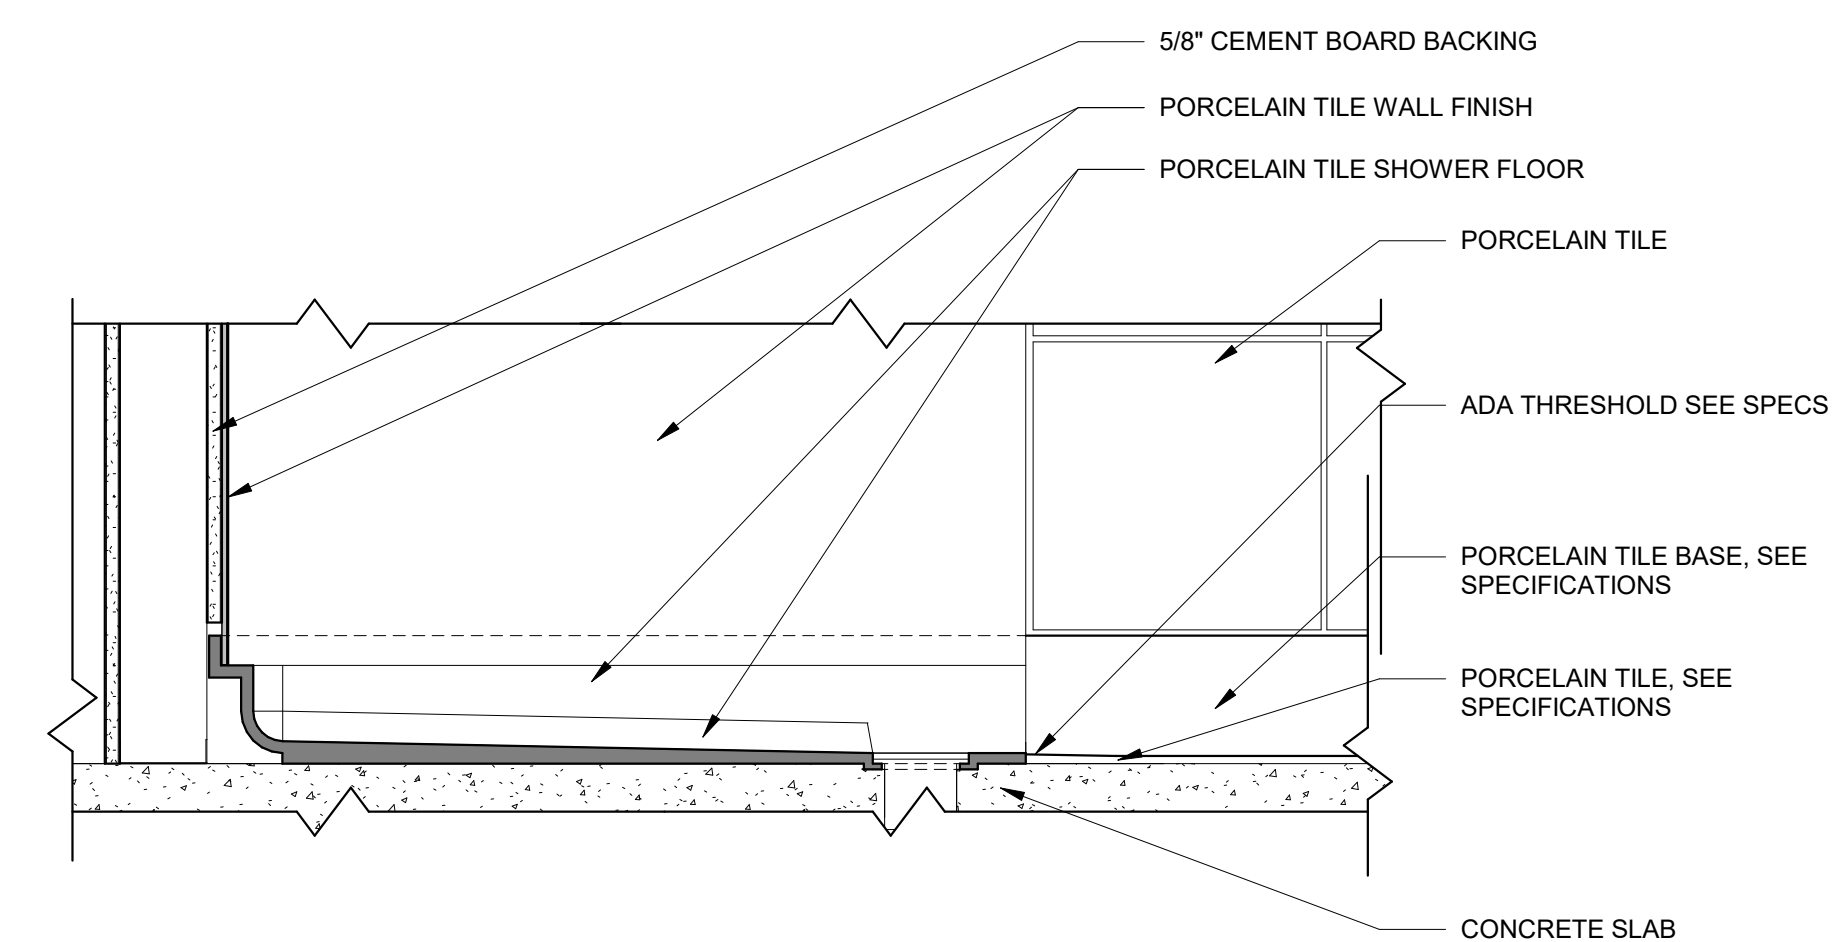

6 SHOWER BASE DETAIL
1 1/2" = 1'-0"

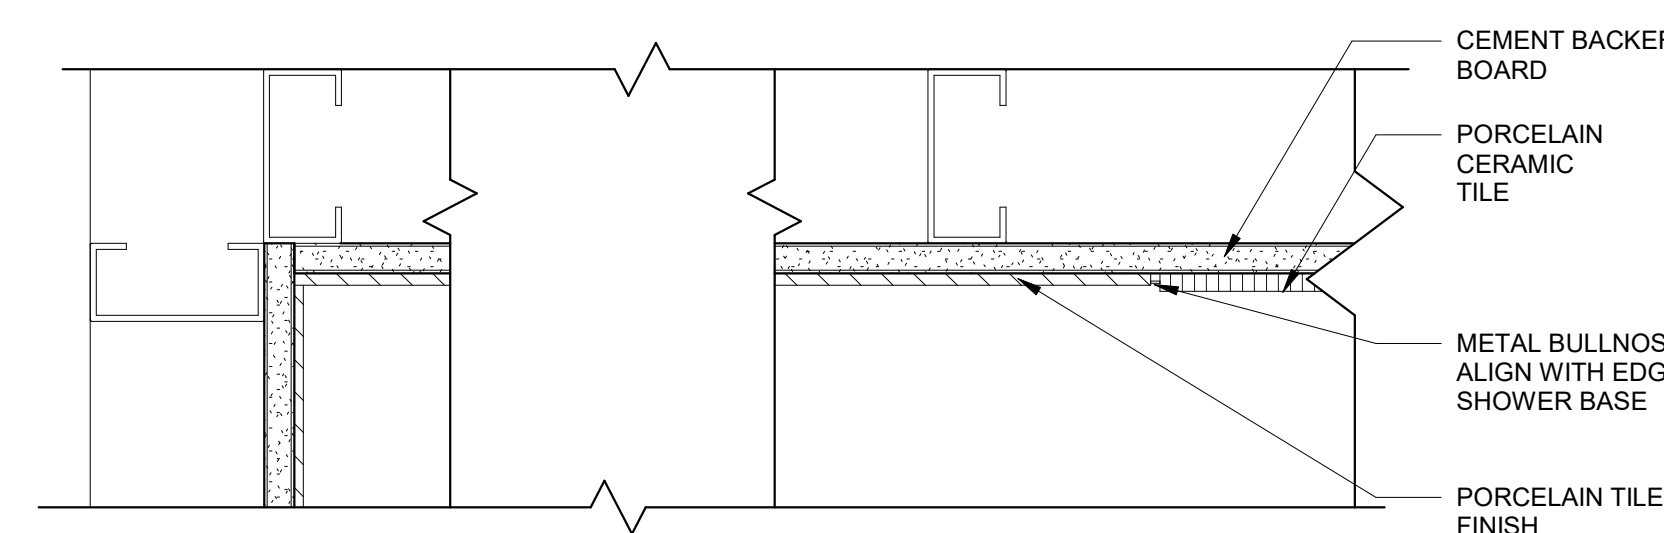

7 SHOWER STALL DETAILS
3" = 1'-0"

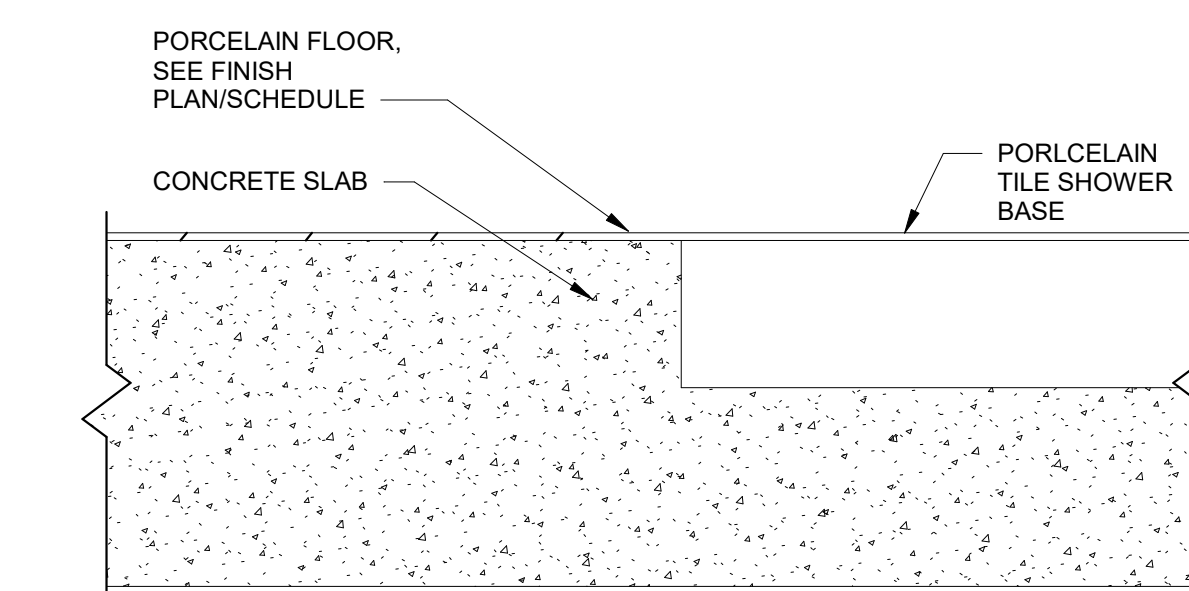

8 SHOWER RECEPTOR
6" = 1'-0"

GENERAL NOTES:

1. SHEET SIZE FOR PROPER SCALE IS 30X42. CONTRACTOR SHALL NOT SCALE DRAWINGS BUT SHALL REQUEST THE DESIRED DIMENSIONS FROM THE ARCHITECT.
2. SEE SHEET G-002 FOR GENERAL NOTES.
3. APPLY 1 1/2" THICK FIREPROOFING AT ALL EXPOSED STEEL WITHIN INTERSTITIAL SPACE AND AT EXPOSED STEEL STRUCTURE ABOVE 3RD FLOOR CEILING, TYP.

SHEET SPECIFIC NOTES:

1. SEE WALL PROTECTION PLAN FOR SPECIFIC LOCATIONS OF WALL PANELS, CORNER GUARDS, BUMPER RAILS AND HANDRAILS.
2. PORCELAIN TILE: SOLID SURFACING, RESINOUS WALL APPLICATION OVER CONCRETE BACKER BOARD. SEE SPECIFICATIONS.
3. COORDINATE SHOWER STALL AND FLOOR LAYOUTS BASED ON DIMENSIONS OF SHOWER FLOOR MANUFACTURER'S ROUGH-IN REQUIREMENTS.

FLOOR FINISH LEGEND:

- EPOXY COATED CONCRETE
- RF - RUBBER FLOORING
- LVT1 - LUXURY VINYL TILE
- RES-6 - RESINOUS FLOORING
- PT1 - PORCELAIN TILE
- PT3 - PORCELAIN TILE
- CPT-1 - CARPET TILE

CONSTRUCTION DOCUMENTS

COMPLIANCE REVIEW COMPLETED	2/23/2024
Revisions:	Date

CONSULTANTS:

TERRASITE DESIGN
1635 DEADWOOD AVENUE
RAPID CITY, SOUTH DAKOTA 57702
PH: (605) 791-1736

Albertson Engineering Inc.

ALBERTSON ENGINEERING, INC.
315 NORTH MAIN AVENUE, SUITE 200
SIOUX FALLS, SOUTH DAKOTA 57104
PH: (605) 274-0880

FARRIS ENGINEERING
OMAHA (BRANCH) | SENECA | COUNCIL BLUFFS
farris-engineering.com | PH: 1.800.843.8434

FARRIS ENGINEERING
12700 WEST DODGE ROAD
OMAHA, NEBRASKA 68154
PH: (402) 330-5900



ARCHITECT

FOURFRONT DESIGN, INC.
517 7TH STREET
RAPID CITY, SOUTH DAKOTA 57701
PH: (605) 342-9470
FAX: (605) 342-2377
WWW.FOURFRONTDESIGN.COM

Drawing Title
FLOOR FINISH PLAN - 3RD LEVEL AND FLOORING TRANSITION DETAILS

Approved: Project Director
Omaha VA Medical Center

Project Title
Design/Construct Sterile Processing Service- Omaha VA Medical Center

Location
4101 Woolworth Ave #4199 Omaha, Ne 68105

Date
11/23/2020

Checked
JL

Drawn
JGC

Project Number
16.2330.A08

Building Number
25

Drawing Number
A-511

Dwg. 52 of 143

Office of
Construction
and Facilities
Management

Department of Veterans Affairs

GENERAL NOTES:

1. SHEET SIZE FOR PROPER SCALE IS 30X42.
CONTRACTOR SHALL NOT SCALE DRAWINGS BUT SHALL REQUEST THE DESIRED DIMENSIONS FROM THE ARCHITECT.
2. SEE SHEET G-002 FOR GENERAL NOTES.
3. APPLY 1 1/2" THICK FIREPROOFING AT ALL EXPOSED STEEL WITHIN INTERSTITIAL SPACE AND AT EXPOSED STEEL STRUCTURE ABOVE 3RD FLOOR CEILING, TYP.

SHEET SPECIFIC NOTES:


1. SEE INTERIOR ELEVATIONS FOR ADDITIONAL DETAILS AND WALL PROTECTION.
2. WHERE WALL PROTECTION WRAPS COLUMNS, PROVIDE COORDINATING CORNER GUARDS AND TRIM FOR A SEAMLESS INSTALLATION.

KEYNOTES:


- 10-21.1 CG-1, VINYL CORNER GUARD, SEE SPECIFICATION.
10-21.2 CG-2, STAINLESS STEEL CORNER GUARD, SEE SPECIFICATION.

WALL PROTECTION LEGEND:

- BUMPER/CRASHRAIL
--- HANDRAIL WITH GUARD
--- RWC: RIGID WALL PROTECTION PANEL 48" ABOVE BASE FINISH (1/4" OVERLAP)
--- TILE PT2 WAINSCOT FULL HT
--- TILE PT2 WAINSCOT 6'-0" AFF
--- RWC: RIGID WALL PANEL AT 8' - 0" ABOVE BASE FINISH

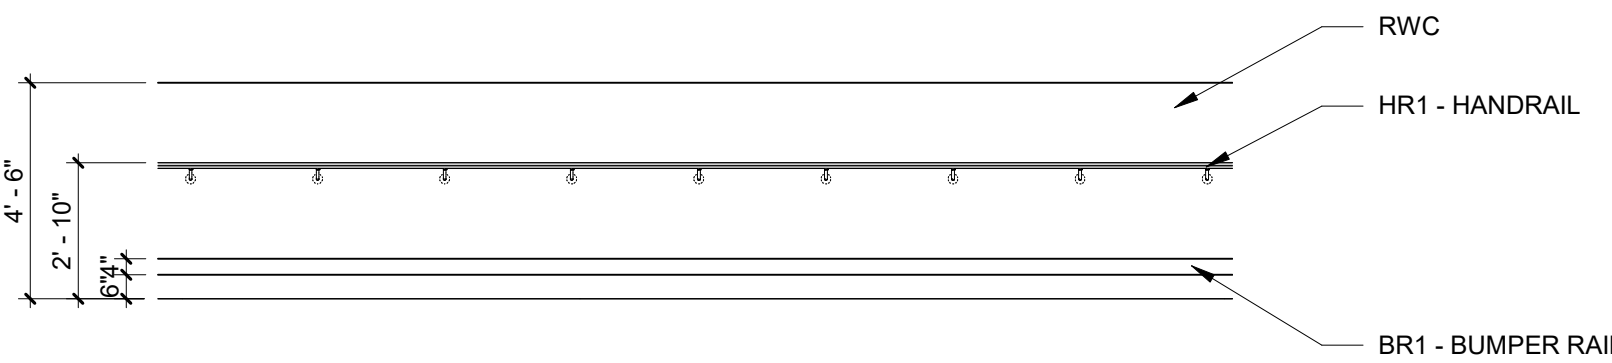


2 CORRIDOR - TYPICAL WALL PROTECTION (AT HANDRAIL)
1/4" = 1'-0"

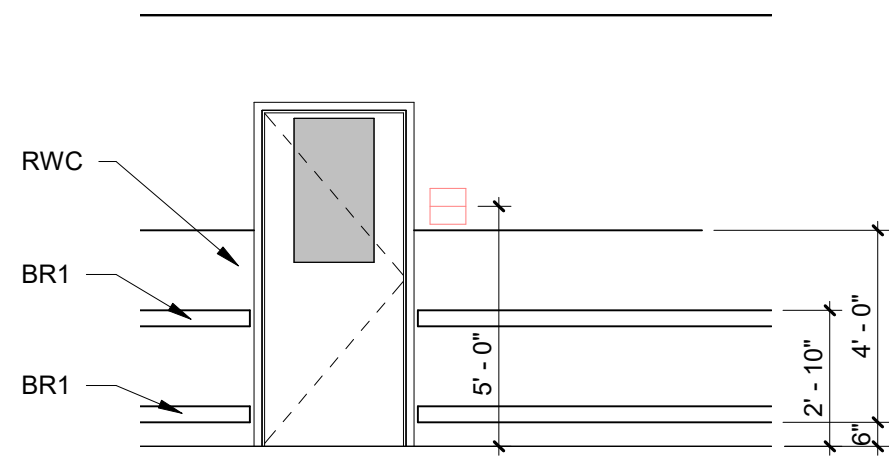



3 CORRIDOR - WALL PROTECTION (NON-HANDRAIL)
1/4" = 1'-0"

1 WALL PROTECTION PLAN - 3RD LEVEL
1/8" = 1'-0"

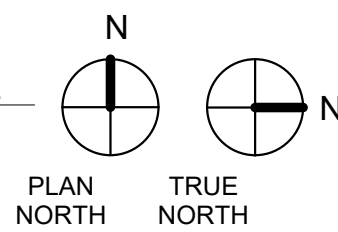

CONSTRUCTION DOCUMENTS

COMPLIANCE REVIEW COMPLETED Revisions: 2/23/2024 Date		CONSULTANTS: TERRASITE DESIGN 1635 DEADWOOD AVENUE RAPID CITY, SOUTH DAKOTA 57702 PH: (605) 791-1736 Albertson Engineering, Inc. 315 NORTH MAIN AVENUE, SUITE 200 SIOUX FALLS, SOUTH DAKOTA 57104 PH: (605) 274-0880 FARRIS ENGINEERING 12700 WEST DODGE ROAD OMAHA, NEBRASKA 68154 PH: (402) 330-5900 <td data-cs="2" data-kind="parent">ARCHITECT FOURFRONT DESIGN, INC. 517 7TH STREET RAPID CITY, SOUTH DAKOTA 57701 PH: (605) 342-9470 FAX: (605) 342-2377 WWW.FOURFRONTDESIGN.COM </td> <td data-cs="2" data-kind="parent">Drawing Title WALL PROTECTION PLANS Approved: Project Director Omaha VA Medical Center</td> <td data-cs="2" data-kind="parent">Project Title Design/Construct Sterile Processing Service- Omaha VA Medical Center Location 4101 Woolworth Ave #4199 Omaha, Ne 68105 Date 11/23/2020 Checked JL Drawn JGC</td> <td data-cs="2" data-kind="parent">Project Number 16.2330.A08 Building Number 25 Drawing Number A-512 Dwg. 53 of 143</td> <td data-cs="2" data-kind="parent">Office of Construction and Facilities Management </td>	ARCHITECT FOURFRONT DESIGN, INC. 517 7TH STREET RAPID CITY, SOUTH DAKOTA 57701 PH: (605) 342-9470 FAX: (605) 342-2377 WWW.FOURFRONTDESIGN.COM	Drawing Title WALL PROTECTION PLANS Approved: Project Director Omaha VA Medical Center	Project Title Design/Construct Sterile Processing Service- Omaha VA Medical Center Location 4101 Woolworth Ave #4199 Omaha, Ne 68105 Date 11/23/2020 Checked JL Drawn JGC	Project Number 16.2330.A08 Building Number 25 Drawing Number A-512 Dwg. 53 of 143	Office of Construction and Facilities Management
---	--	---	--	---	--	---	--

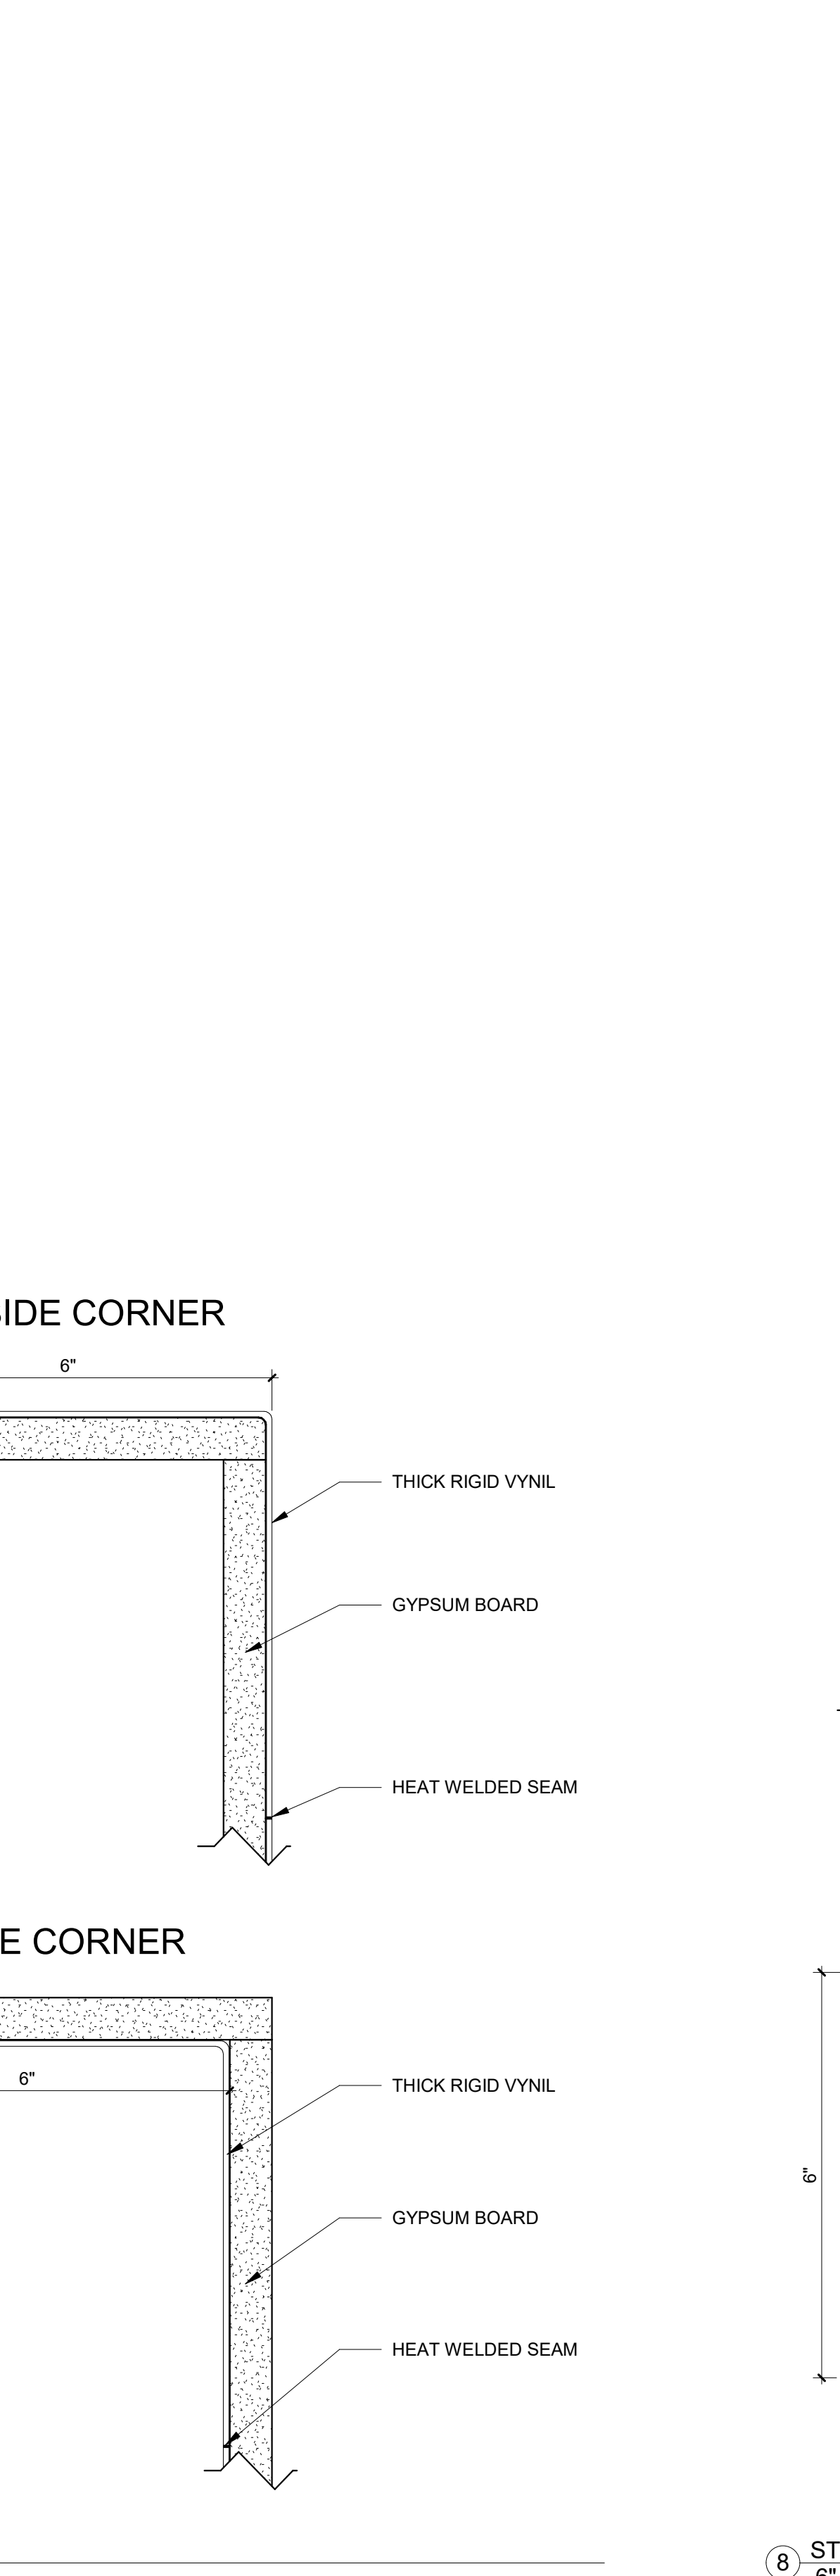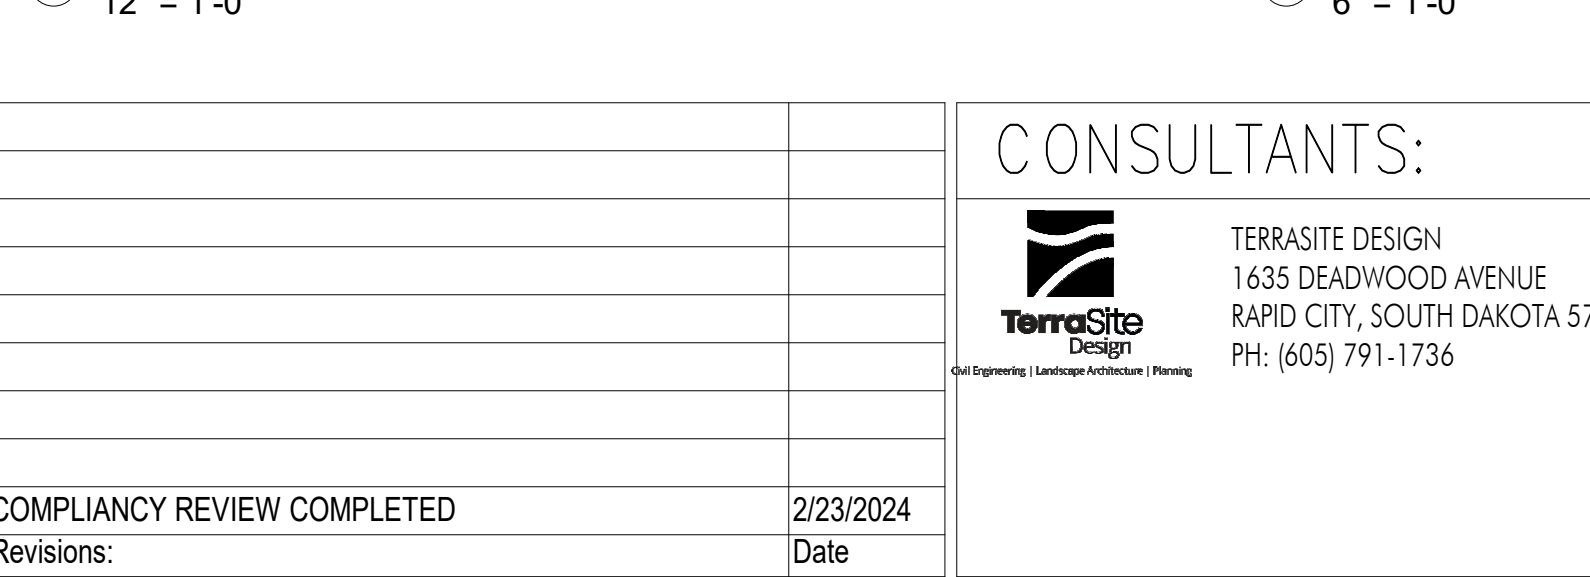

GENERAL NOTES:


1. SHEET SIZE FOR PROPER SCALE IS 30X42. CONTRACTOR SHALL NOT SCALE DRAWINGS BUT SHALL REQUEST THE DESIRED DIMENSIONS FROM THE ARCHITECT.
2. SEE SHEET G-002 FOR GENERAL NOTES.
3. APPLY 1 1/2" THICK FIREPROOFING AT ALL EXPOSED STEEL WITHIN INTERSTITIAL SPACE AND AT EXPOSED STEEL STRUCTURE ABOVE 3RD FLOOR CEILING, TYP.

SHEET SPECIFIC NOTES:


1. BRING BOTTOM OF CORNER GUARDS 4" AFF.

KEYNOTES:

- | | |
|-------|--|
| 09-30 | PT-1, PORCELAIN TILE, SEE SPECIFICATION. |
| 09-31 | PT-2, PORCELAIN TILE, SEE SPECIFICATION. |
| 09-33 | METAL BULLNOSE TRIM, SEE SPECIFICATION. |
| 09-34 | METAL COVE TRIM, SEE SPECIFICATION. |
| 09-52 | SOFFIT, SEE ROOM FINISH SCHEDULE FOR PAINT. |
| 10-15 | WARDROBE HOOKS, SEE SPECIFICATION. |
| 10-16 | FULL LENGTH MIRROR, SEE SPECIFICATION. |
| 10-18 | 24" GRAB BAR, SEE SPECIFICATION. |
| 10-22 | MIRROR, SEE SPECIFICATION. |
| 10-23 | 18" GRAB BAR, SEE SPECIFICATION. |
| 10-24 | 36" GRAB BAR, SEE SPECIFICATION. |
| 10-25 | 42" GRAB BAR, SEE SPECIFICATION. |
| 10-26 | RWC, RIGID VINYL WALL PROTECTION, SEE SPECIFICATION. |
| 10-29 | SURFACE MOUNTED TOILET PAPER HOLDER, SEE SPECIFICATION. |
| 10-30 | SURFACE MOUNTED PAPER TOWEL DISPENSER, SEE SPECIFICATION. |
| 10-37 | SOAP DISPENSER (A5075), VA PROVIDED, CONTRACTOR INSTALLED. |
| 10-50 | LOCKERS, SEE DETAILS ON SHEET. |
| 10-53 | ADA BENCH, SEE SPECIFICATION. |
| 22-01 | PLUMBING FIXTURE (REF. MECHANICAL). |

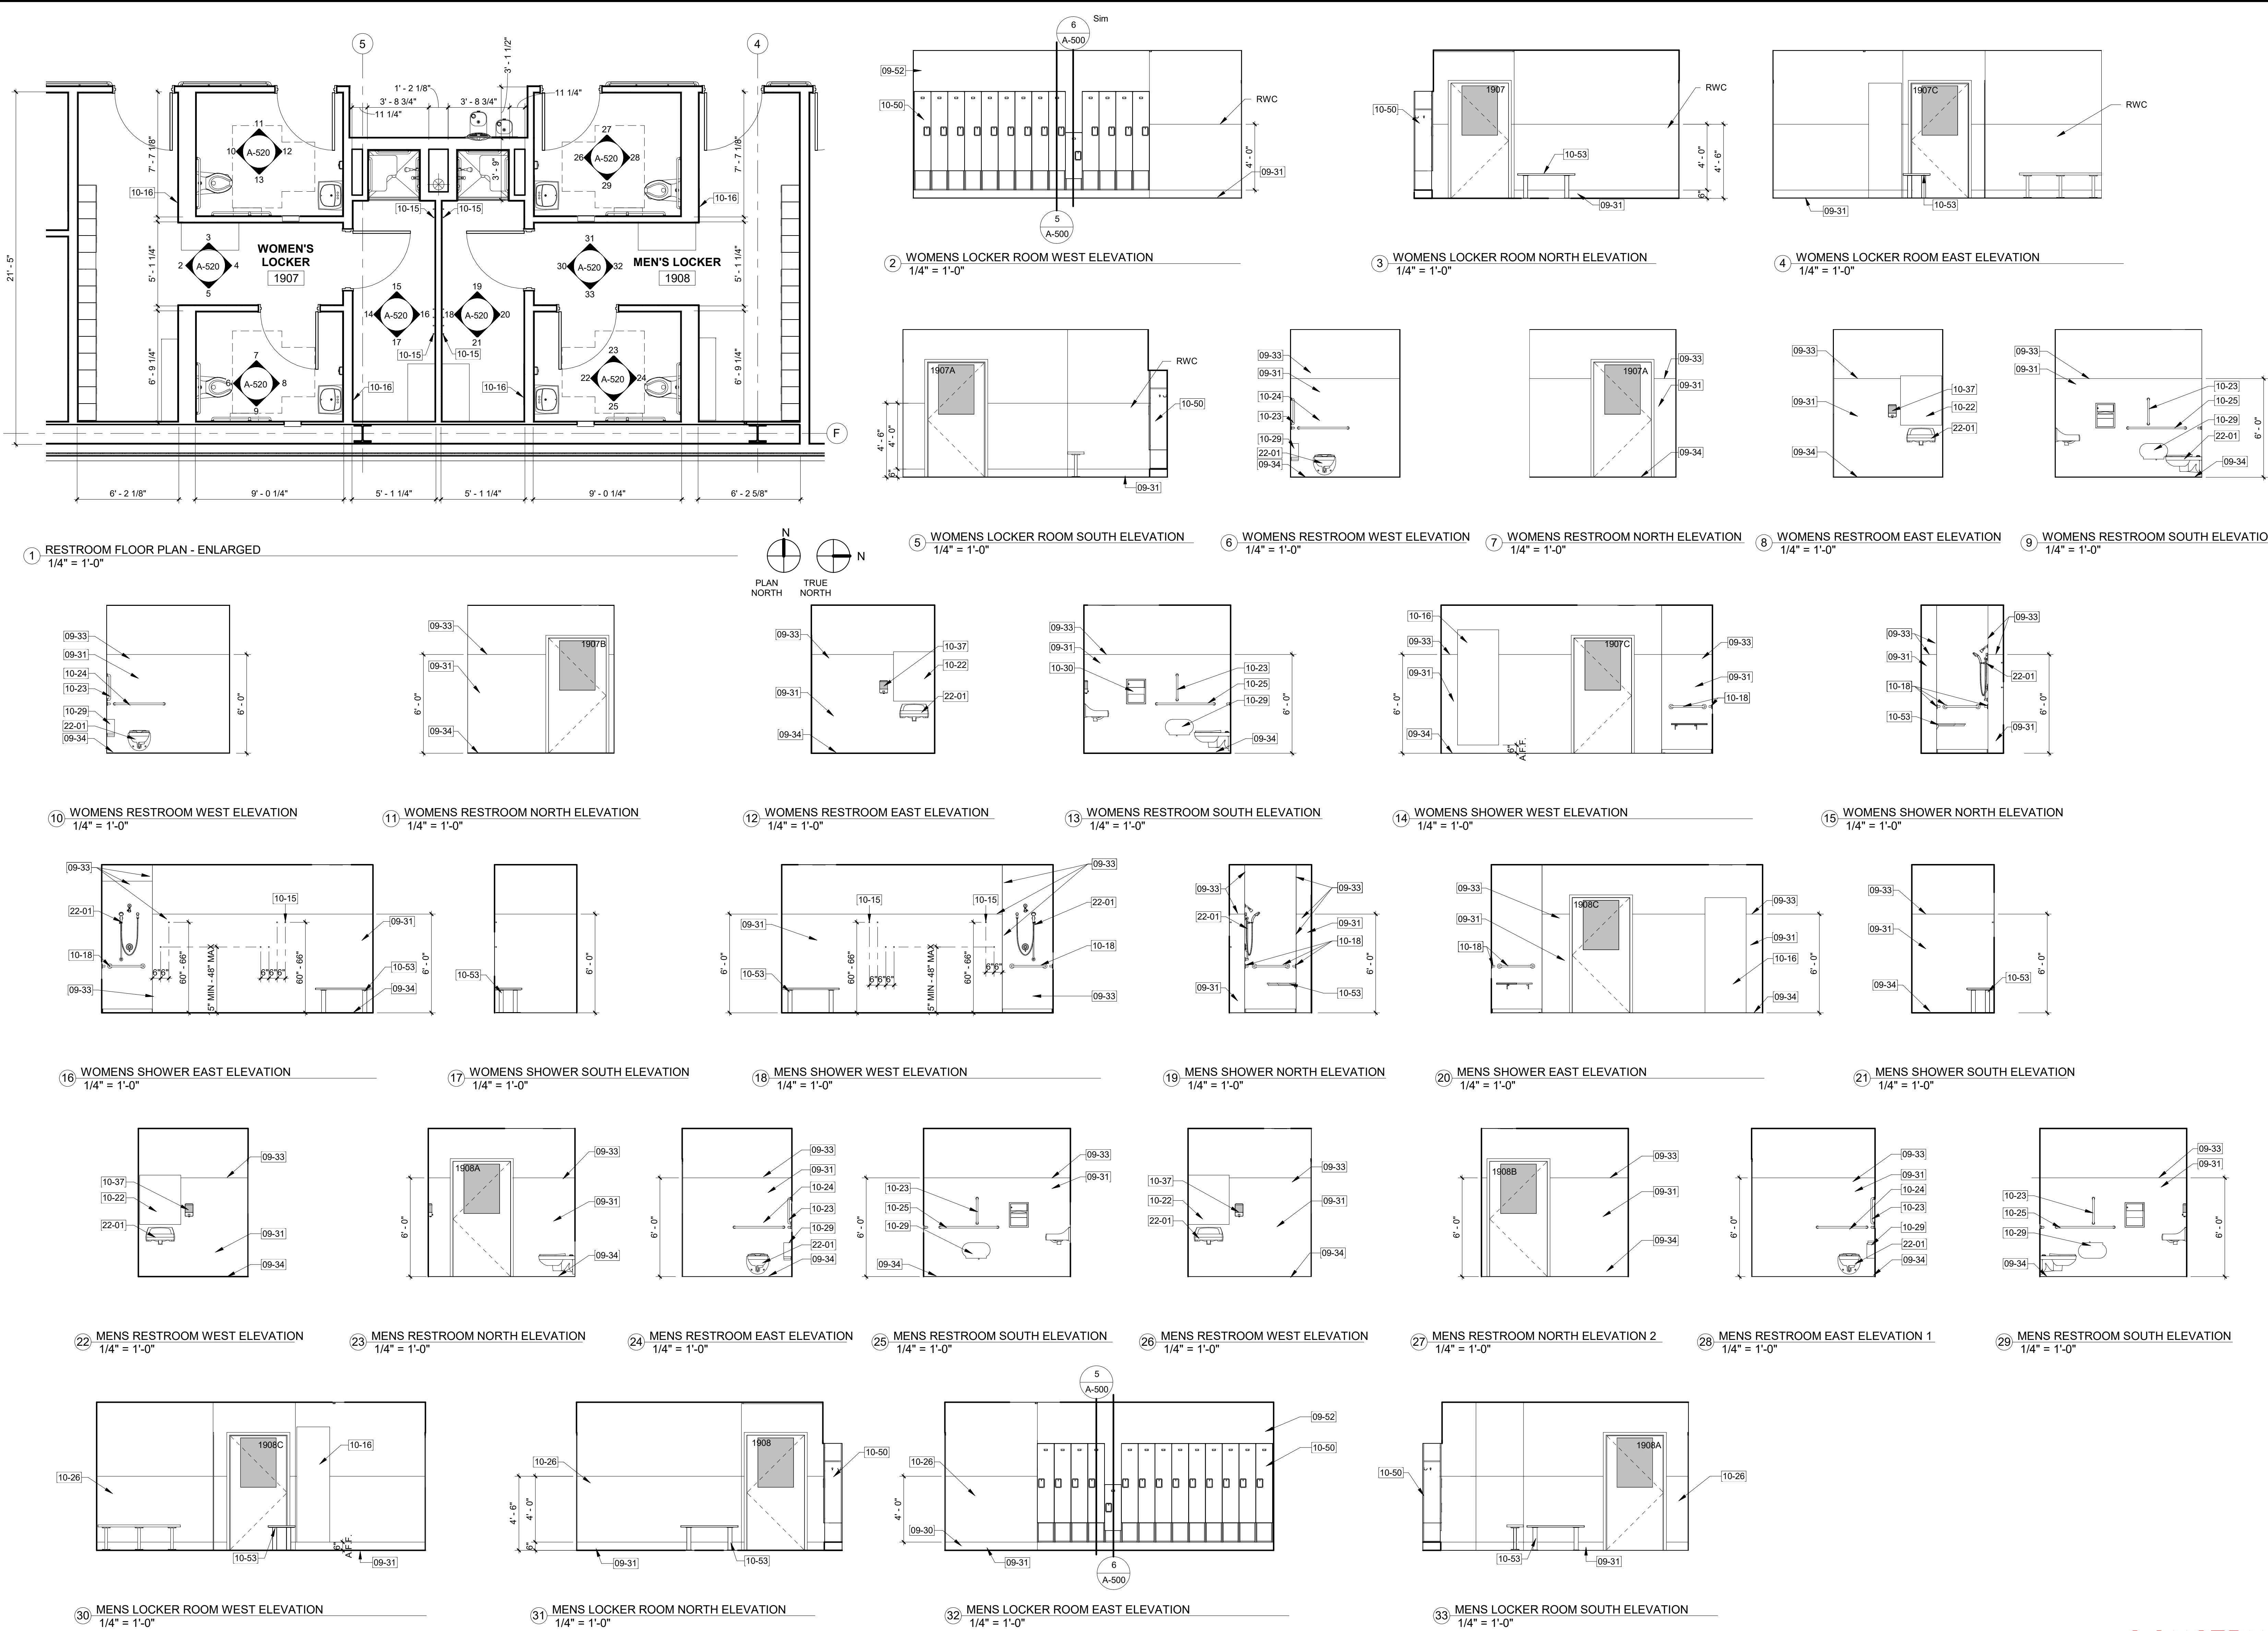

CONSTRUCTION DOCUMENTS

 		CONSULTANTS:  TERRASITE DESIGN 1635 DEADWOOD AVENUE RAPID CITY, SOUTH DAKOTA 57702 PH: (605) 791-1736  ALBERTSON ENGINEERING, INC. 315 NORTH MAIN AVENUE, SUITE 200 SIOUX FALLS, SOUTH DAKOTA 57104 PH: (605) 274-0880  FARRIS ENGINEERING 12700 WEST DODGE ROAD OMAHA, NEBRASKA 68154 PH: (402) 330-5900   FOURFRONT DESIGN, INC. 517 7TH STREET RAPID CITY, SOUTH DAKOTA 57701 PH: (605) 342-9470 FAX: (605) 342-2377 WWW.FOURFRONTDESIGN.COM 		ARCHITECT  FOURFRONT DESIGN, INC. 517 7TH STREET RAPID CITY, SOUTH DAKOTA 57701 PH: (605) 342-9470 FAX: (605) 342-2377 WWW.FOURFRONTDESIGN.COM 		Drawing Title ENLARGED PLAN AND INTERIOR ELEVATIONS Approved: Project Director Omaha VA Medical Center		Project Title Design/Construct Sterile Processing Service- Omaha VA Medical Center Location 4101 Woolworth Ave #4199 Omaha, Ne 68105 Date 11/23/2020 Checked JL Drawn JGC		Project Number 16.2330.A08 Building Number 25 Drawing Number A-520 Dwg. 55 of 143		Office of Construction and Facilities Management  Department of Veterans Affairs	
COMPLIANCY REVIEW COMPLETED		2/23/2024											
Revisions:		Date											

GENERAL NOTES:


























1. SHEET SIZE FOR PROPER SCALE IS 30X42. CONTRACTOR SHALL NOT SCALE DRAWINGS BUT SHALL REQUEST THE DESIRED DIMENSIONS FROM THE ARCHITECT.
2. SEE SHEET G-002 FOR GENERAL NOTES.
3. APPLY 1 1/2" THICK FIREPROOFING AT ALL EXPOSED STEEL WITHIN INTERSTITIAL SPACE AND AT EXPOSED STEEL STRUCTURE ABOVE 3RD FLOOR CEILING, TYP.

SHEET SPECIFIC NOTES:

1. BRING BOTTOM OF CORNER GUARDS 4" AFF.

KEYNOTES:

- 09-45 CORNER GUARD, SEE SPECIFICATION.
09-66 RES6, EPOXY FLOOR/COVE, SEE SPECIFICATION.
10-22 MIRROR, SEE SPECIFICATION.
10-26 RWC, RIGID VINYL WALL PROTECTION, SEE SPECIFICATION.
10-30 SURFACE MOUNTED PAPER TOWEL DISPENSER, SEE SPECIFICATION.
10-37 SOAP DISPENSER (A5075), VA PROVIDED, CONTRACTOR INSTALLED.
10-39 STAINLESS STEEL UTILITY SHELF (A5135), SEE SPECIFICATION.
22-01 PLUMBING FIXTURE (REF. MECHANICAL)

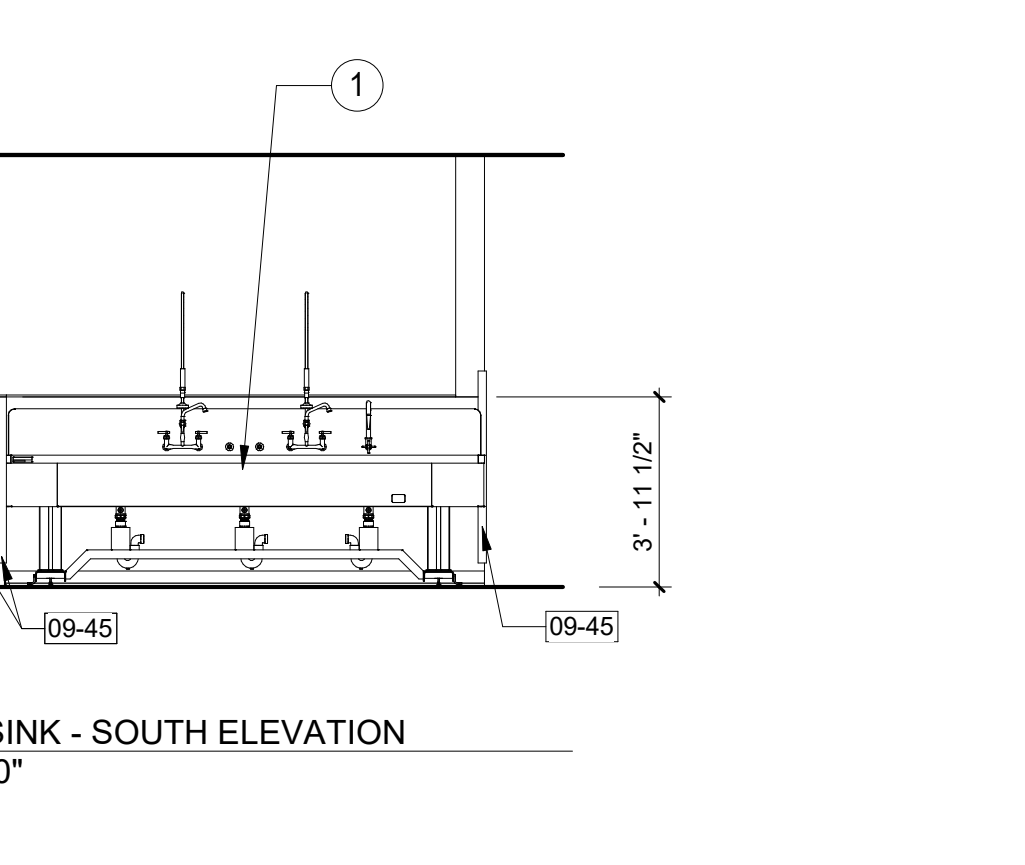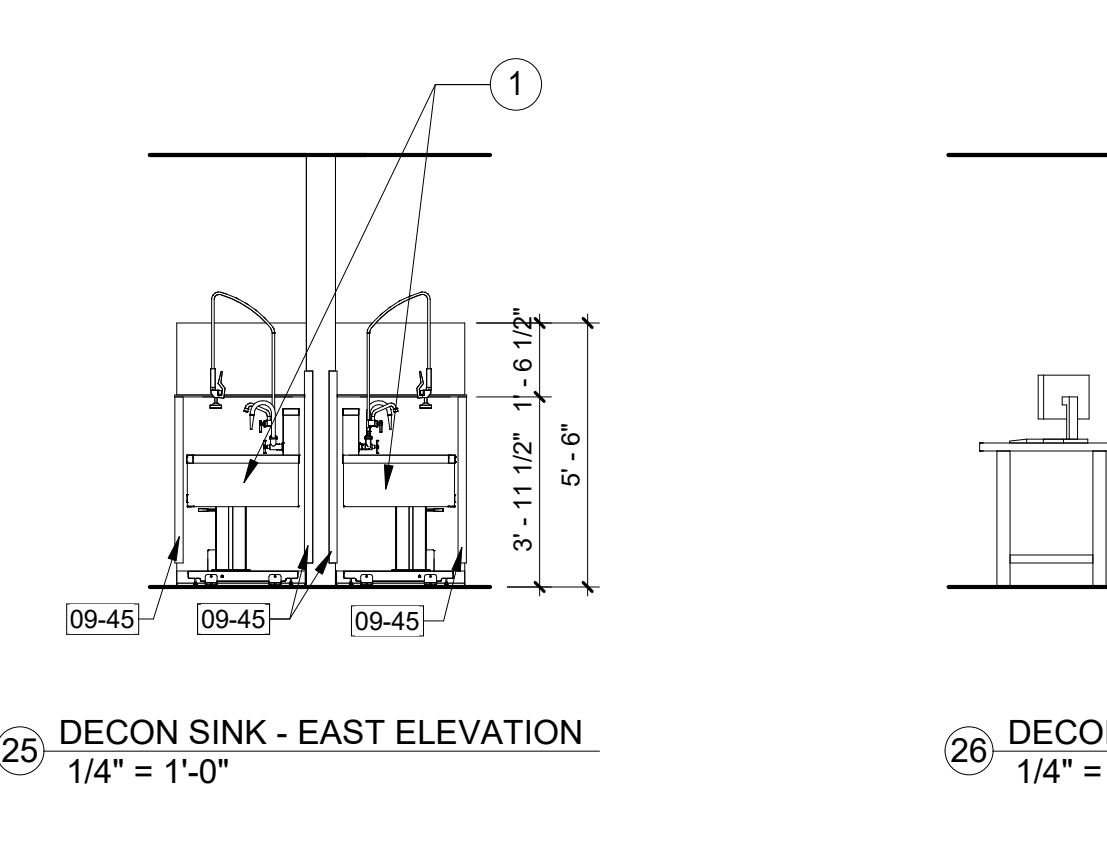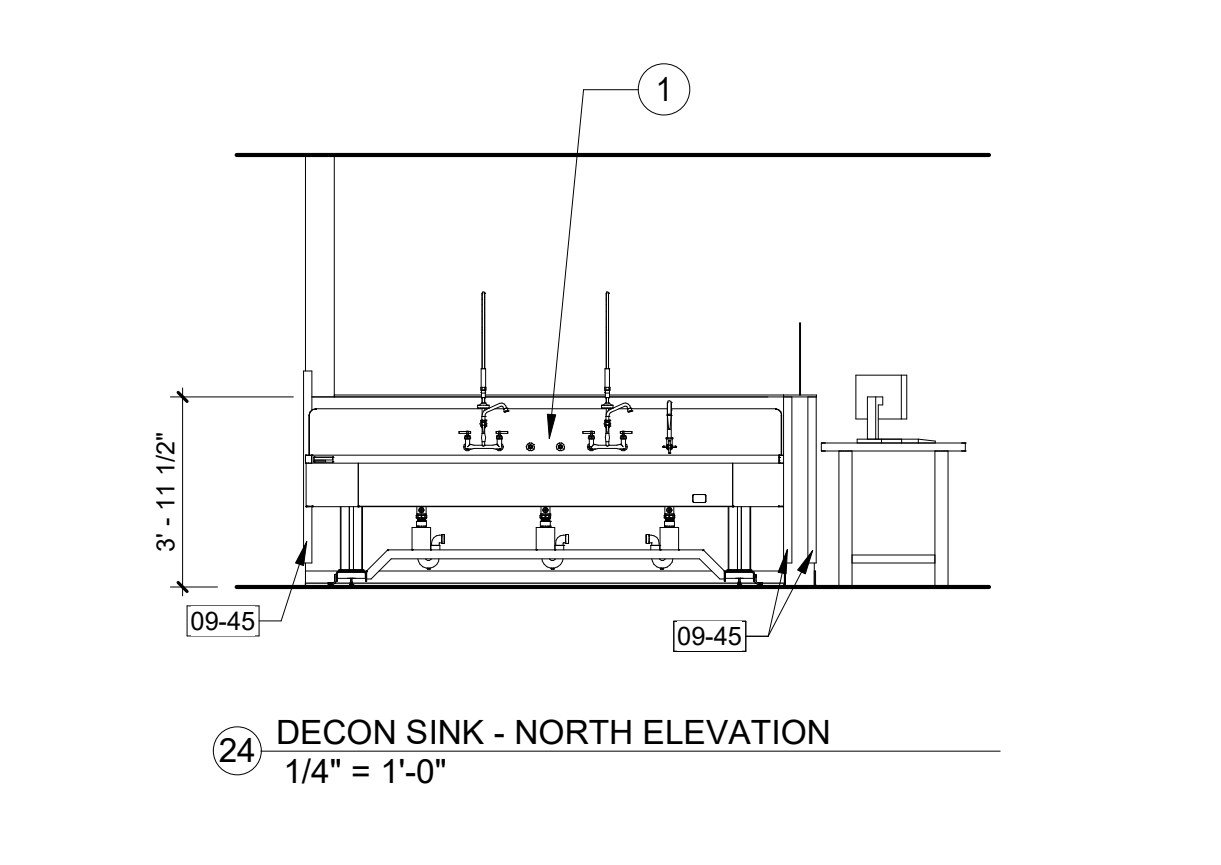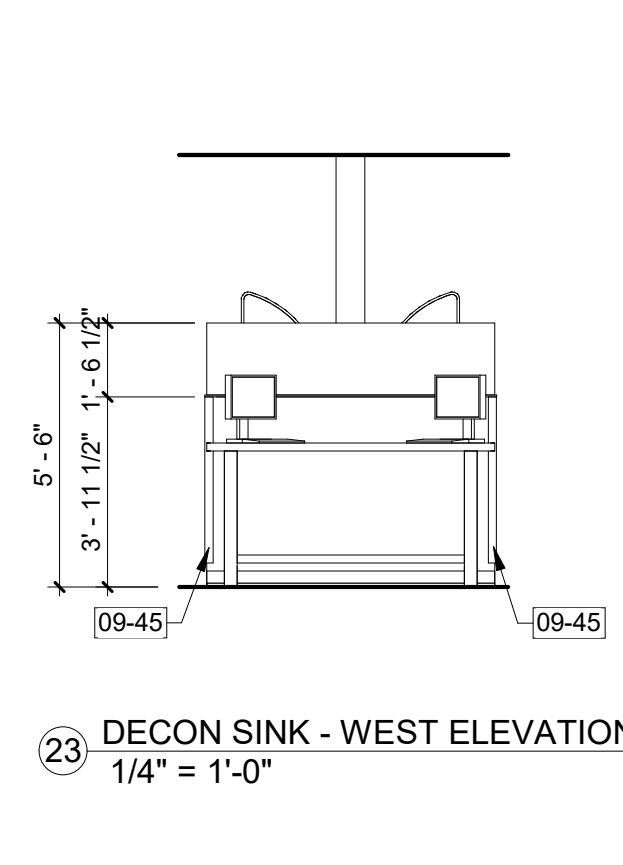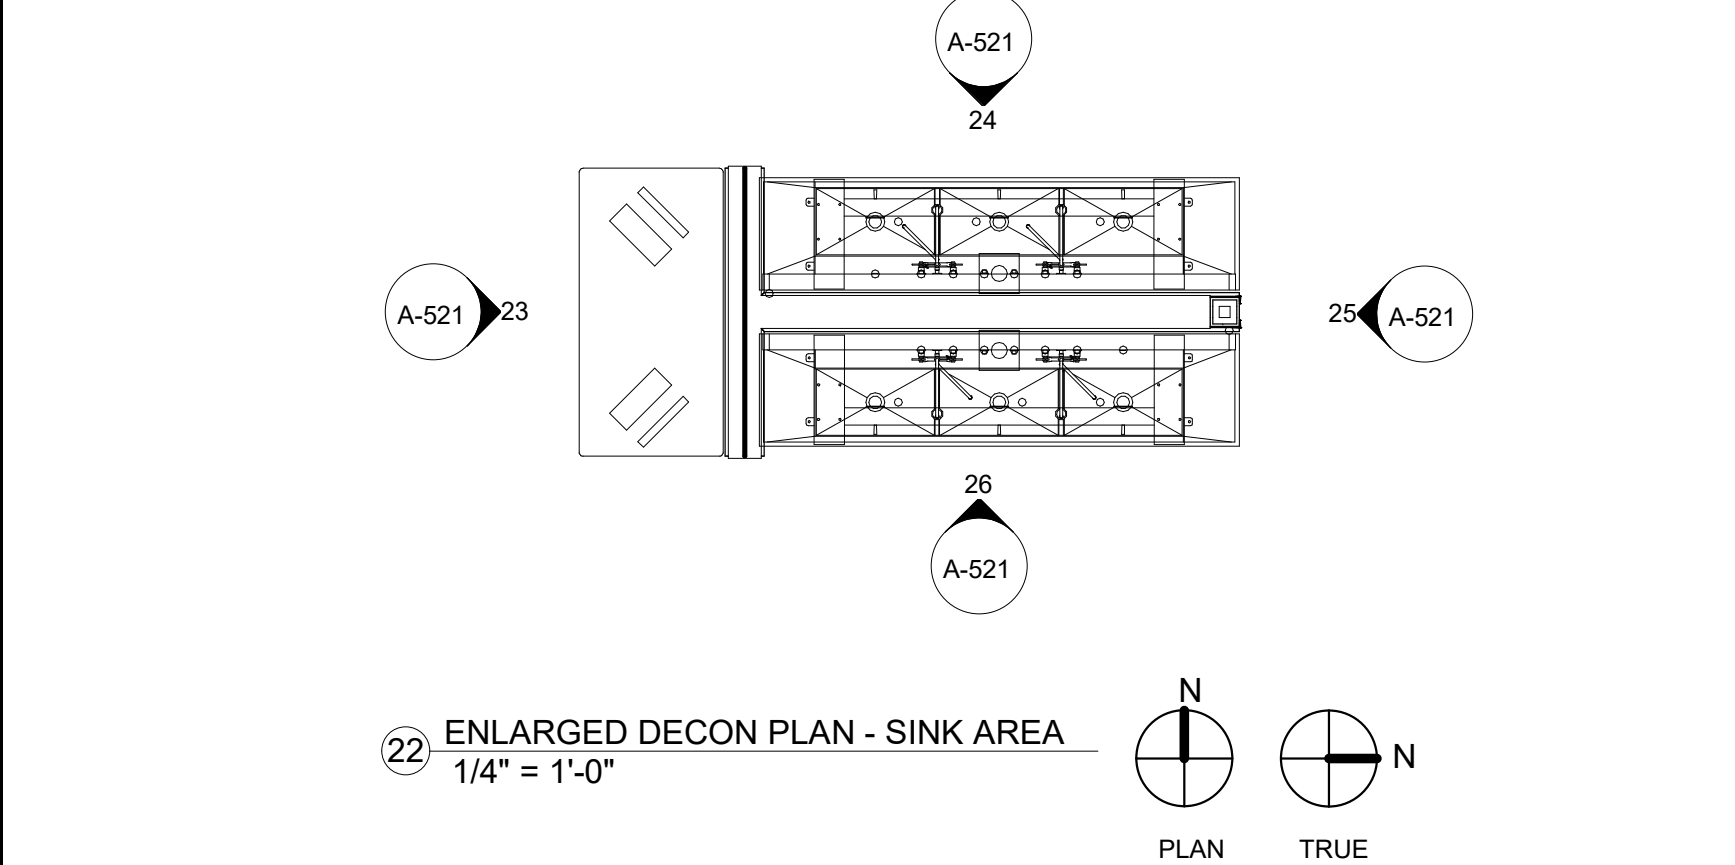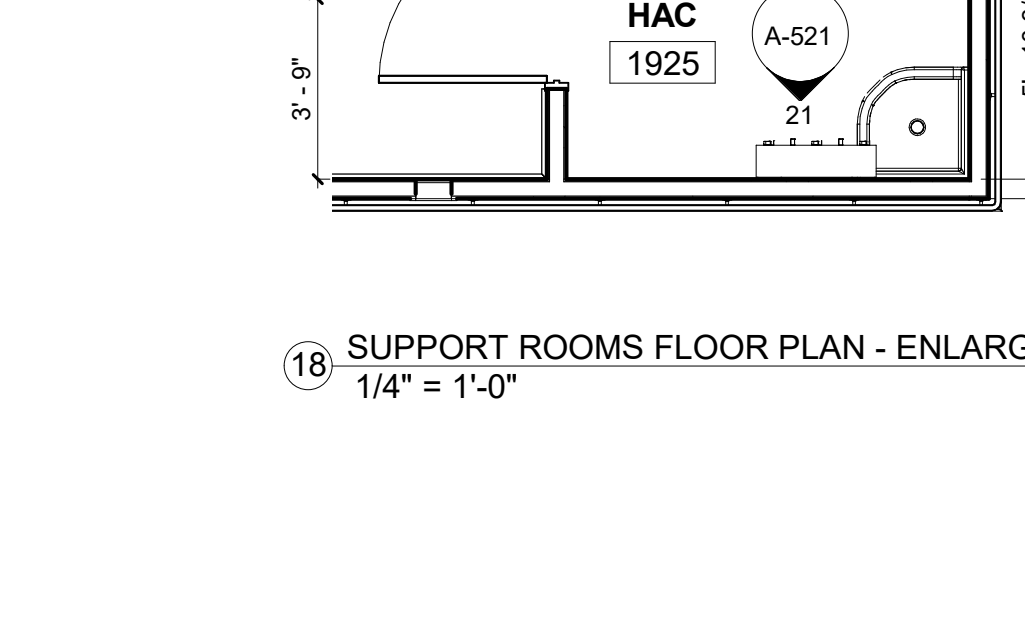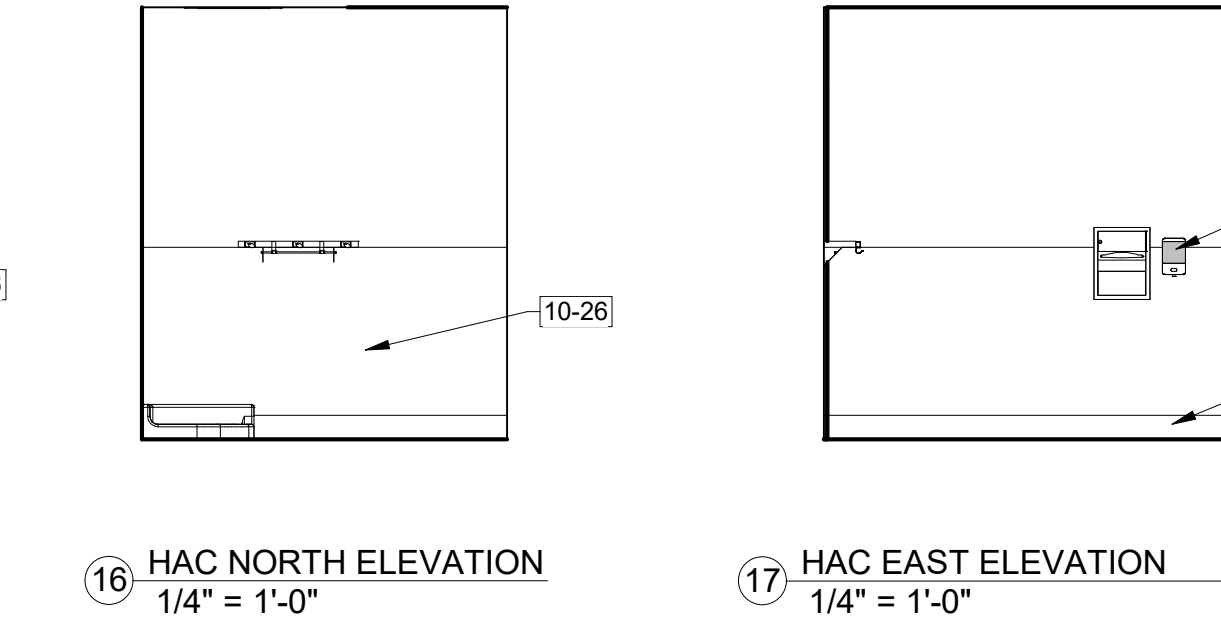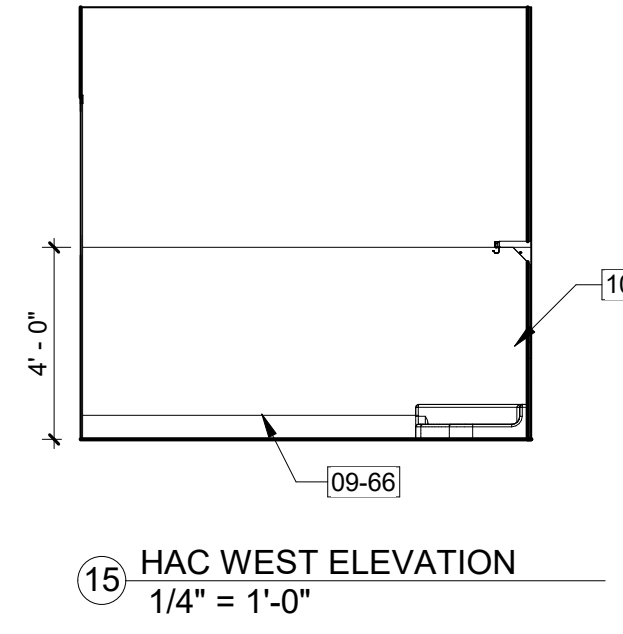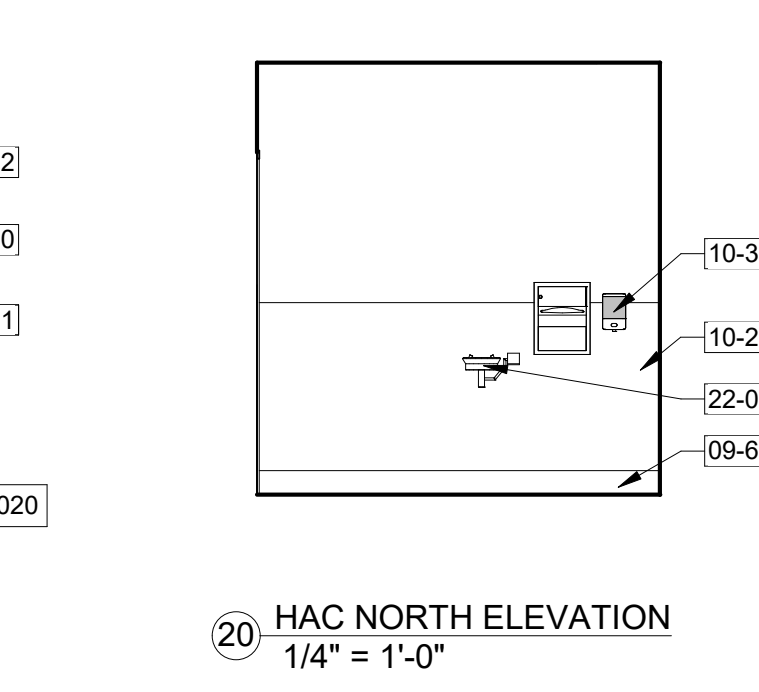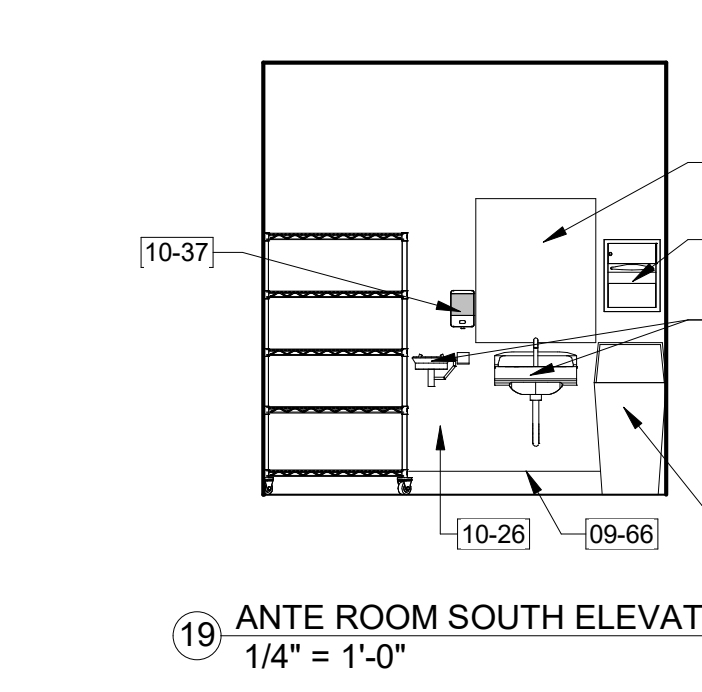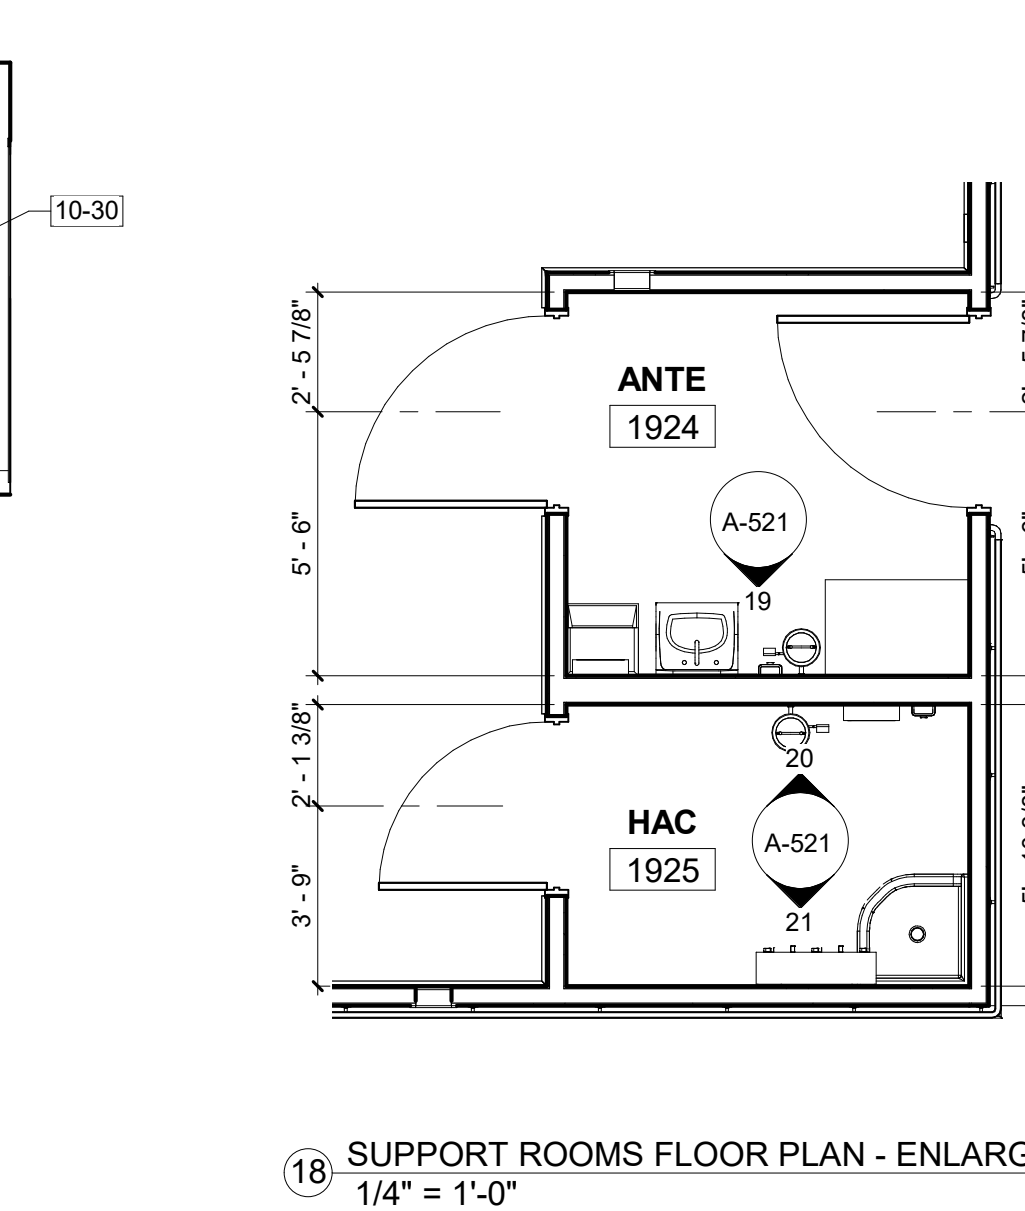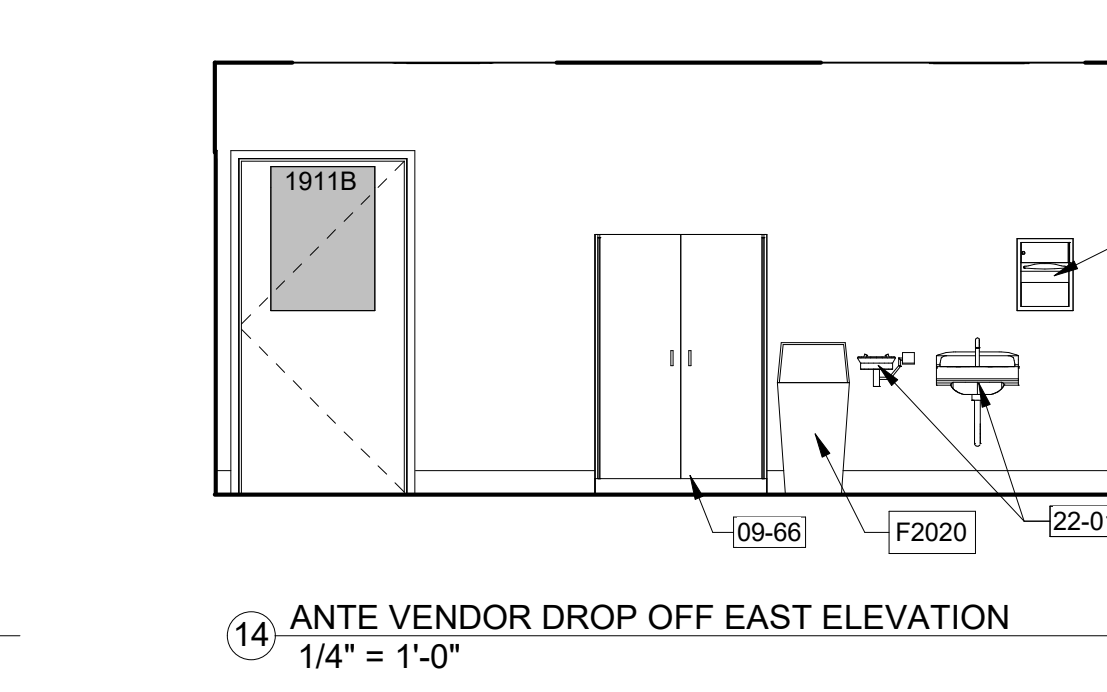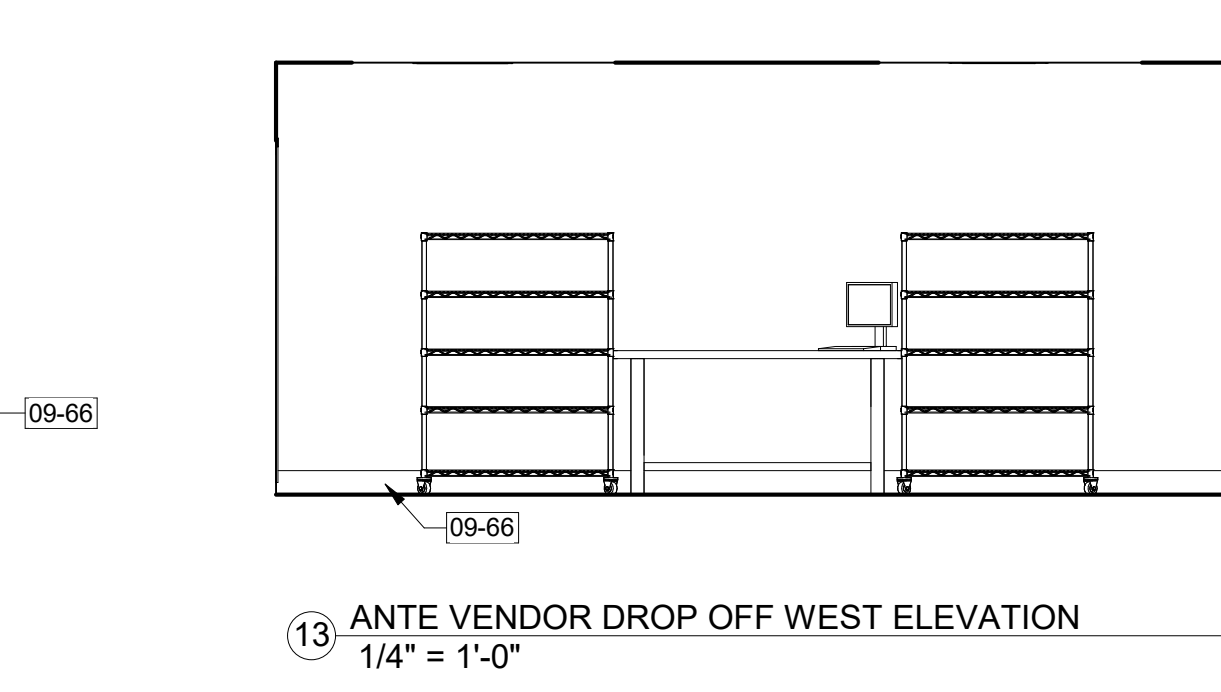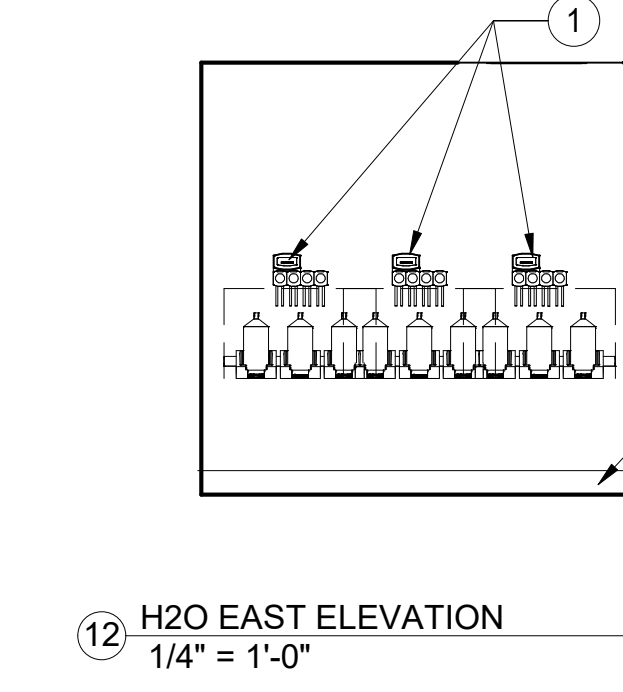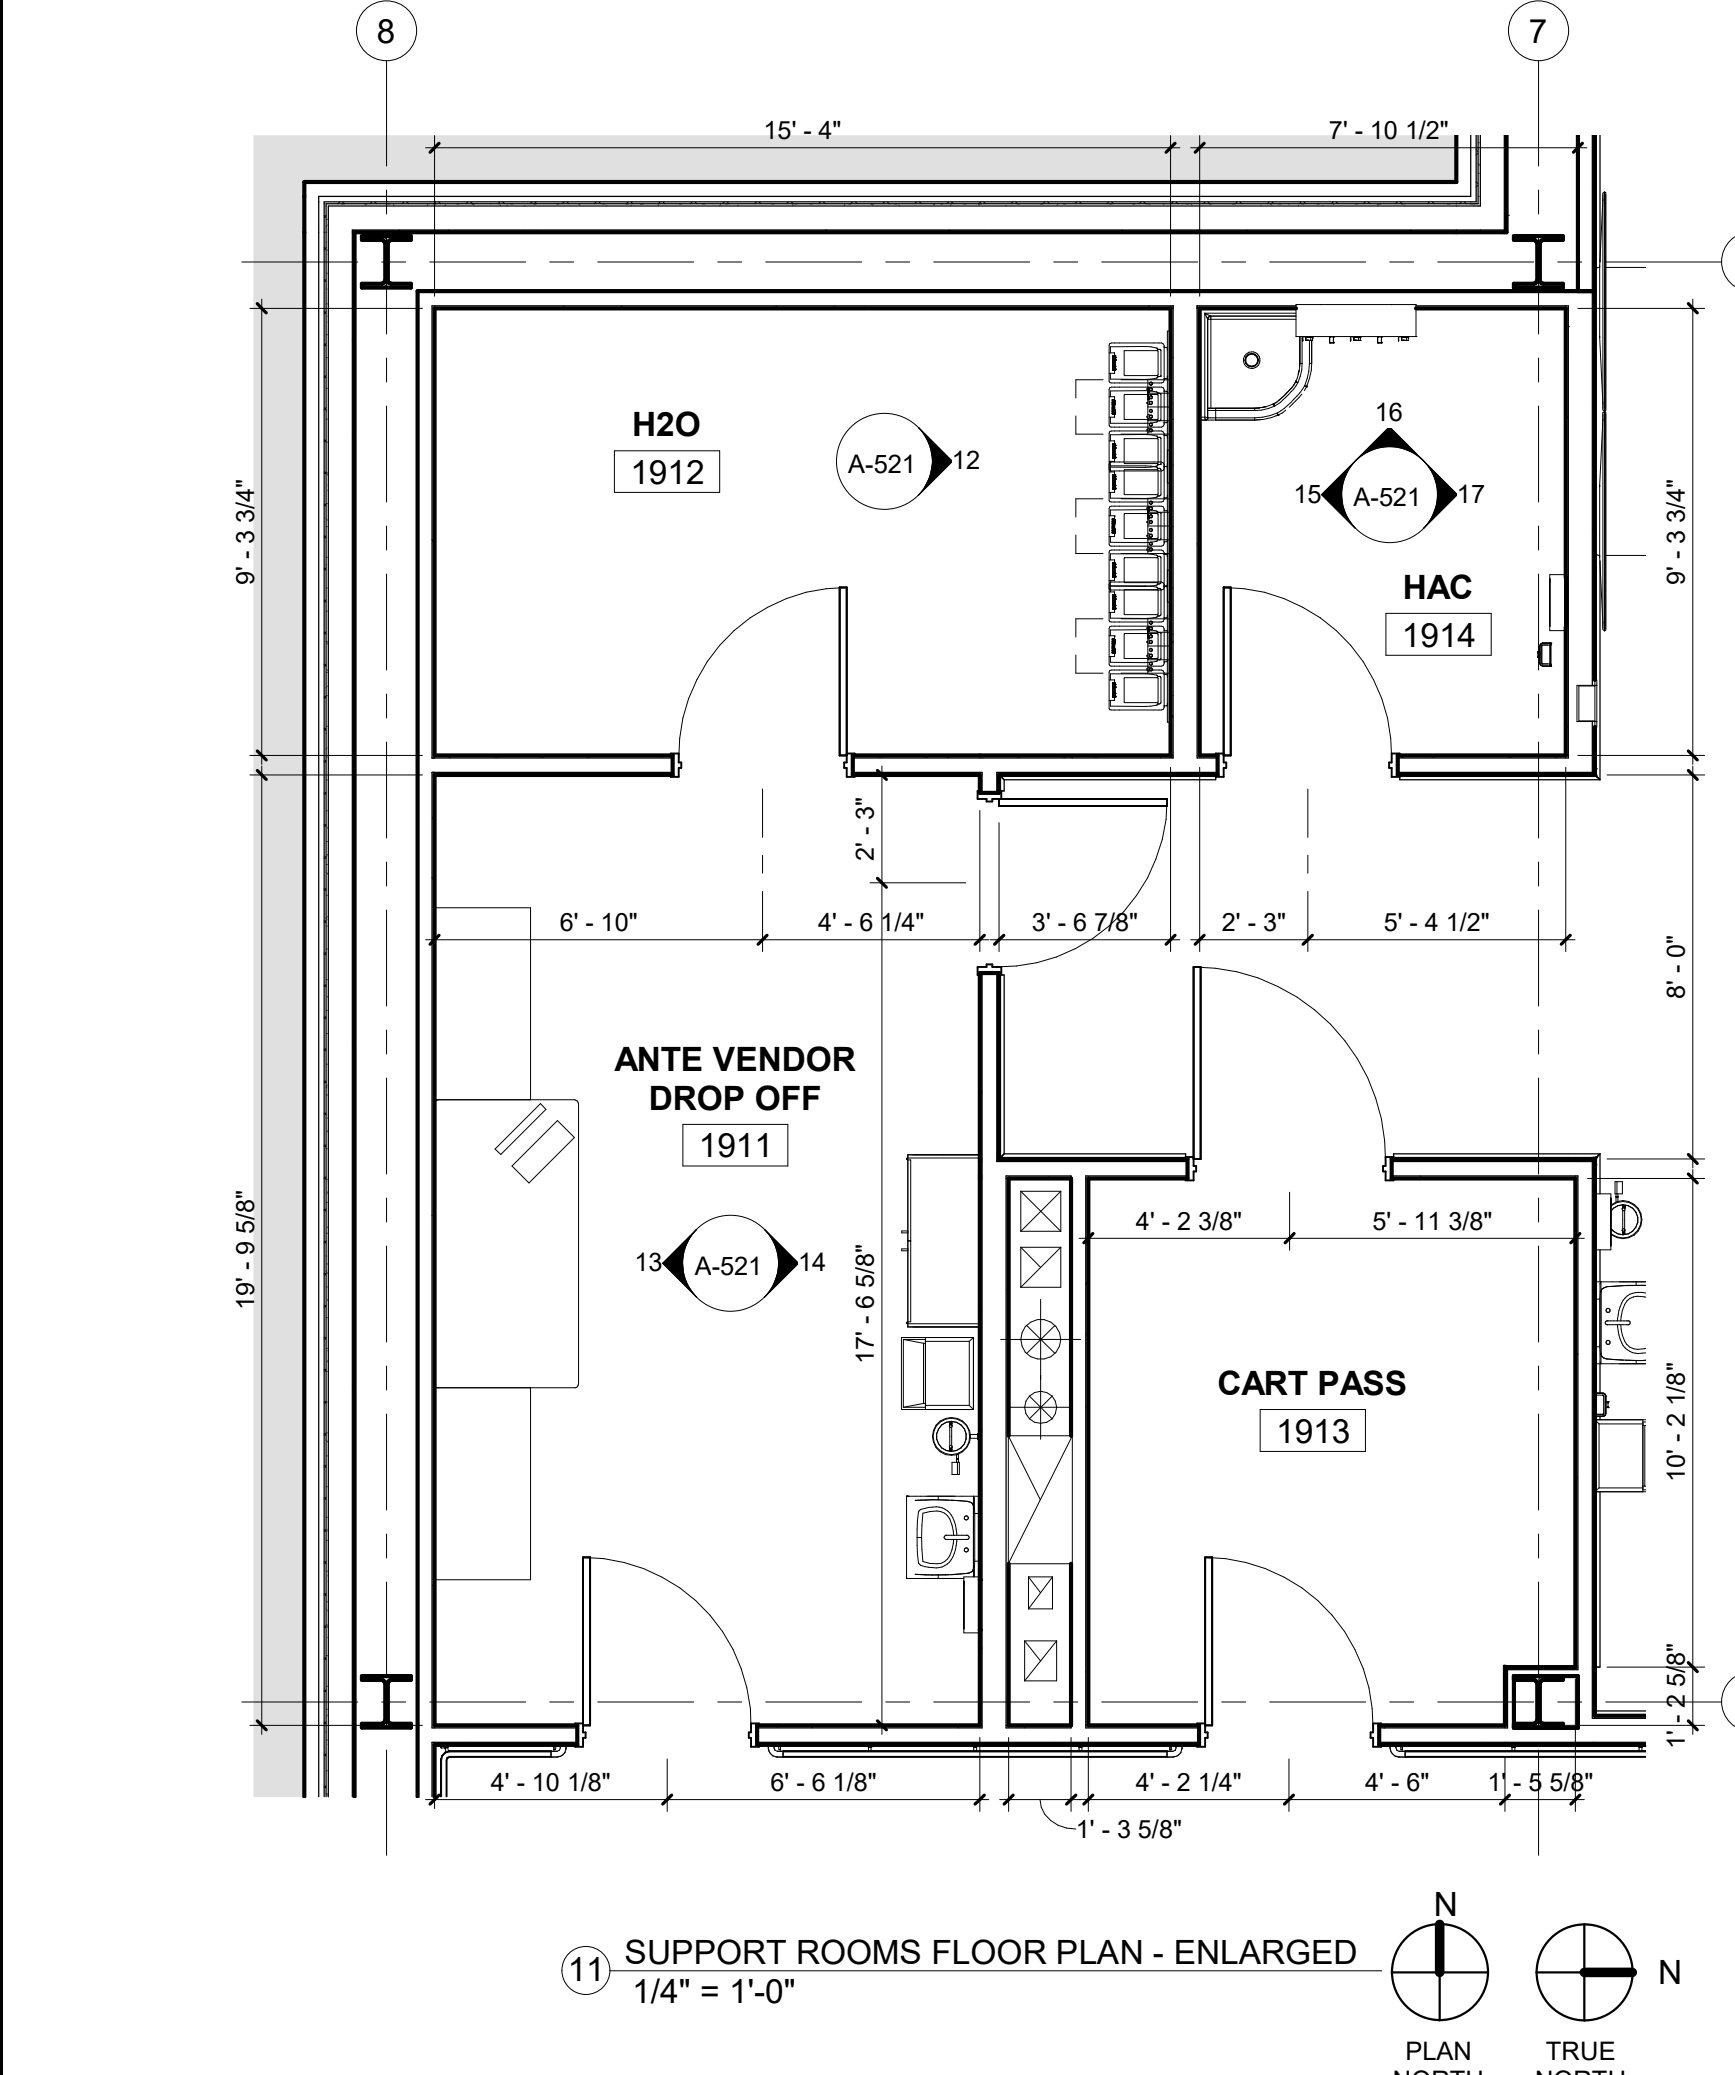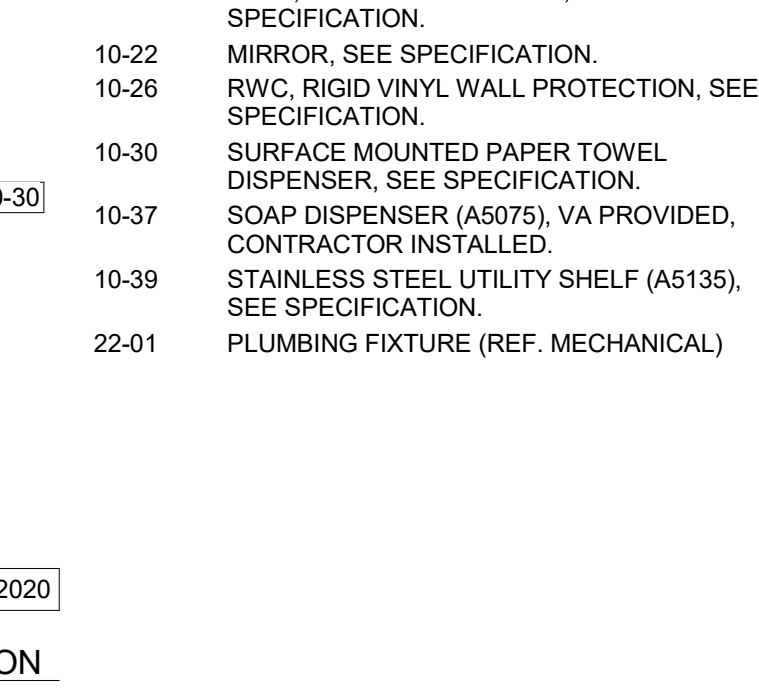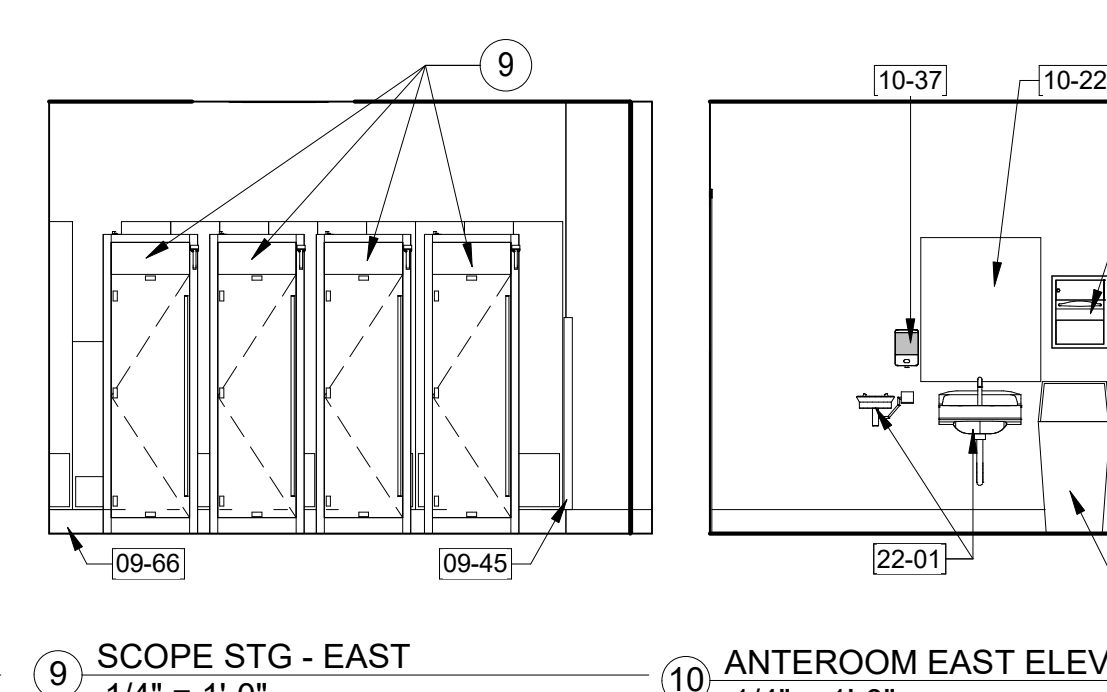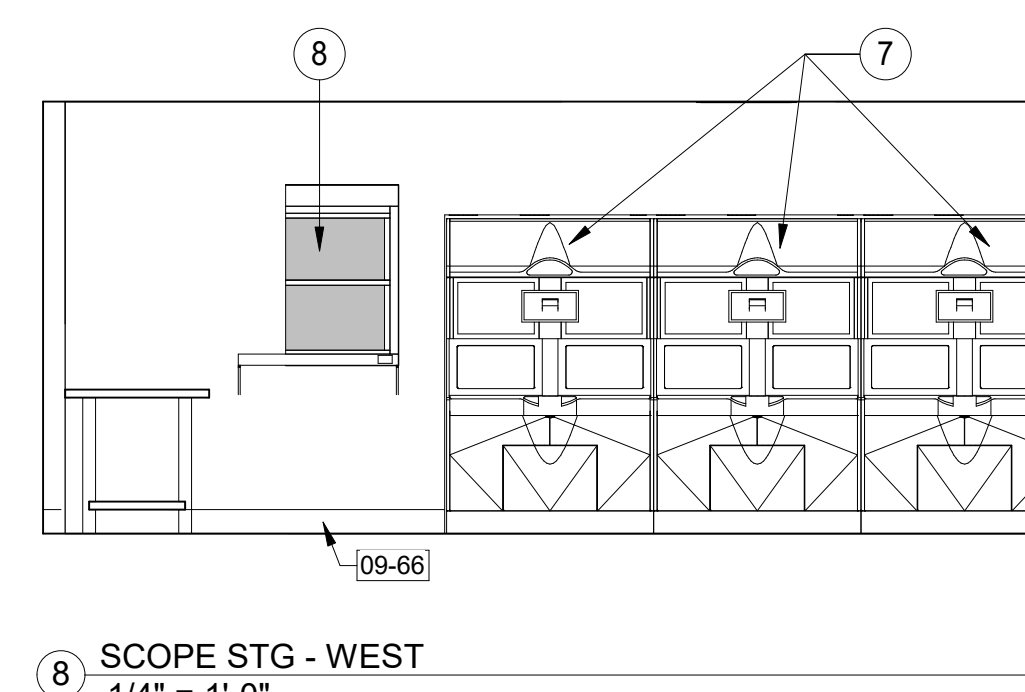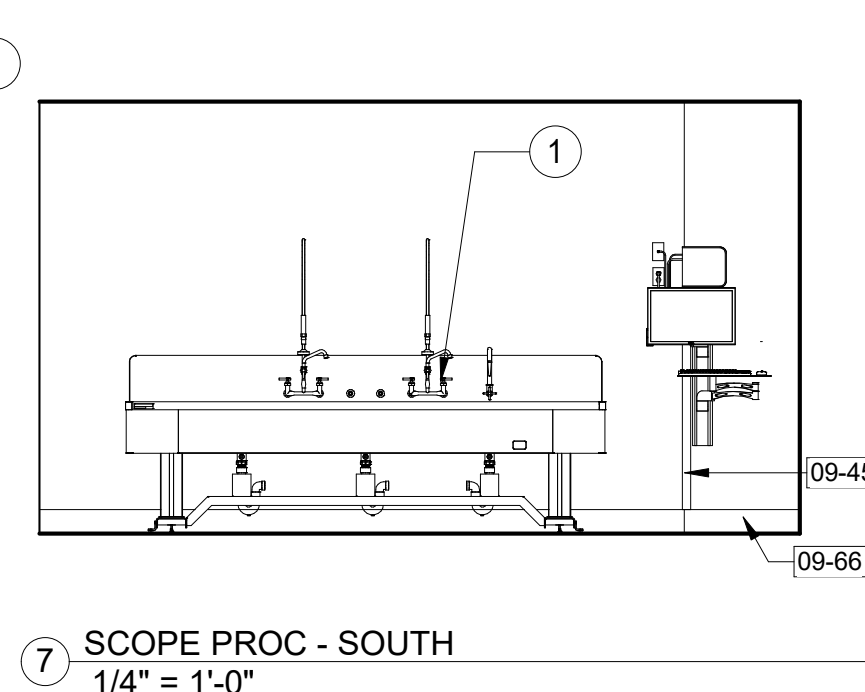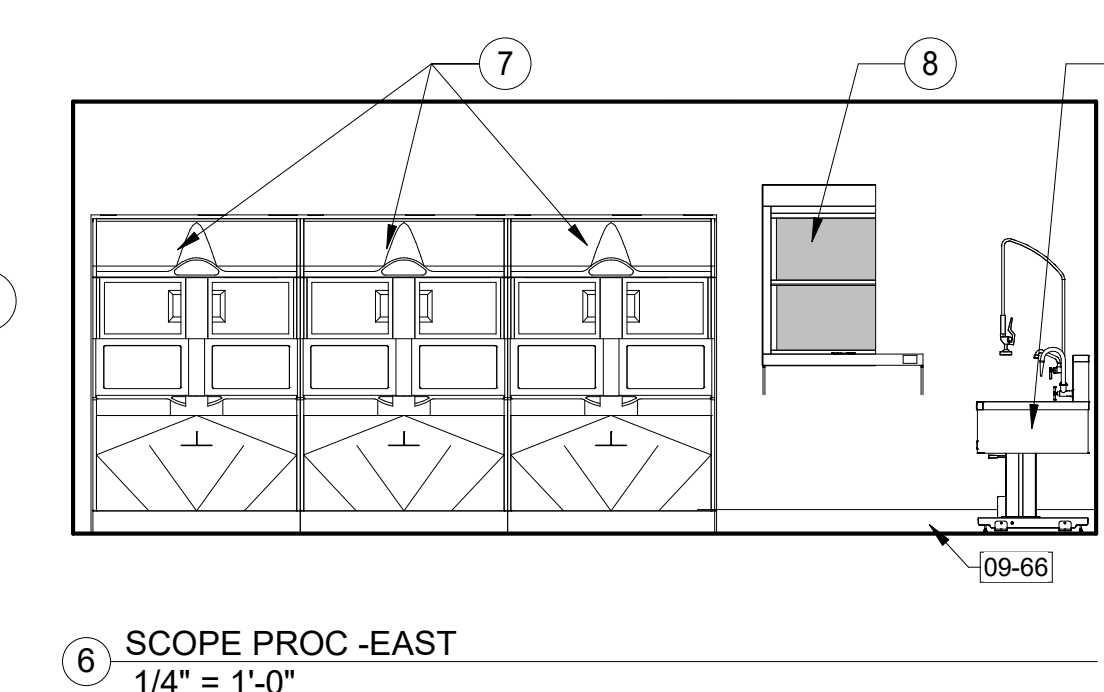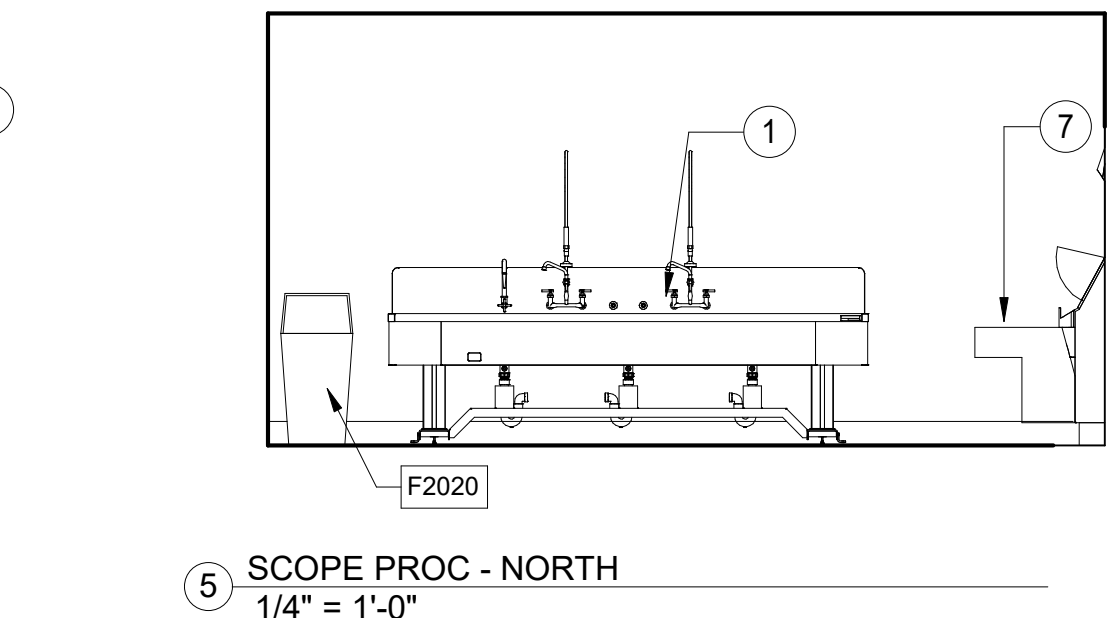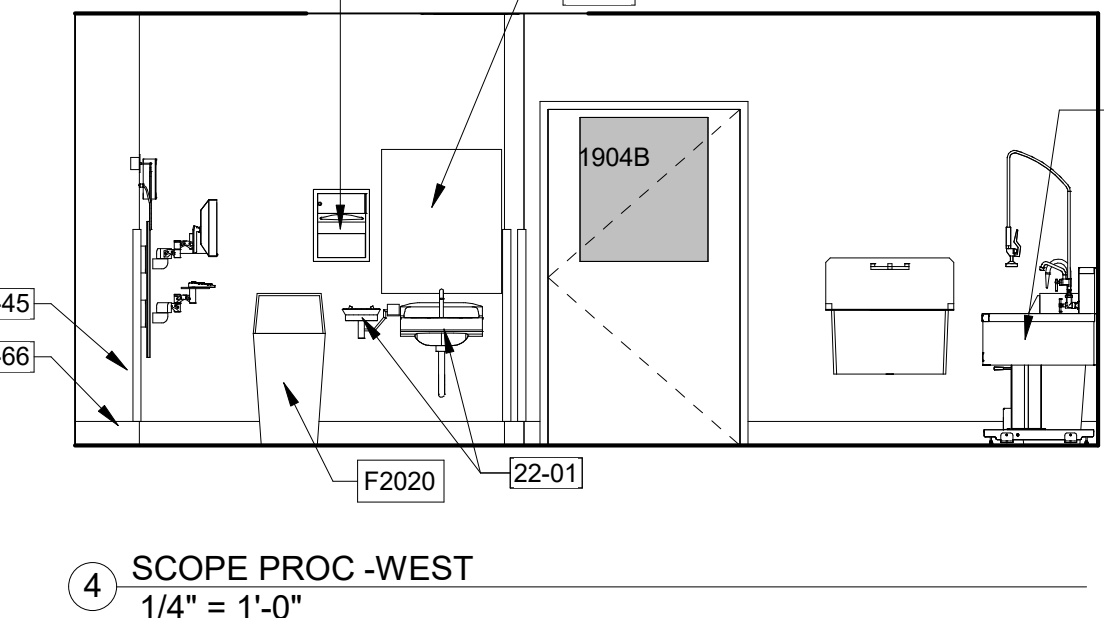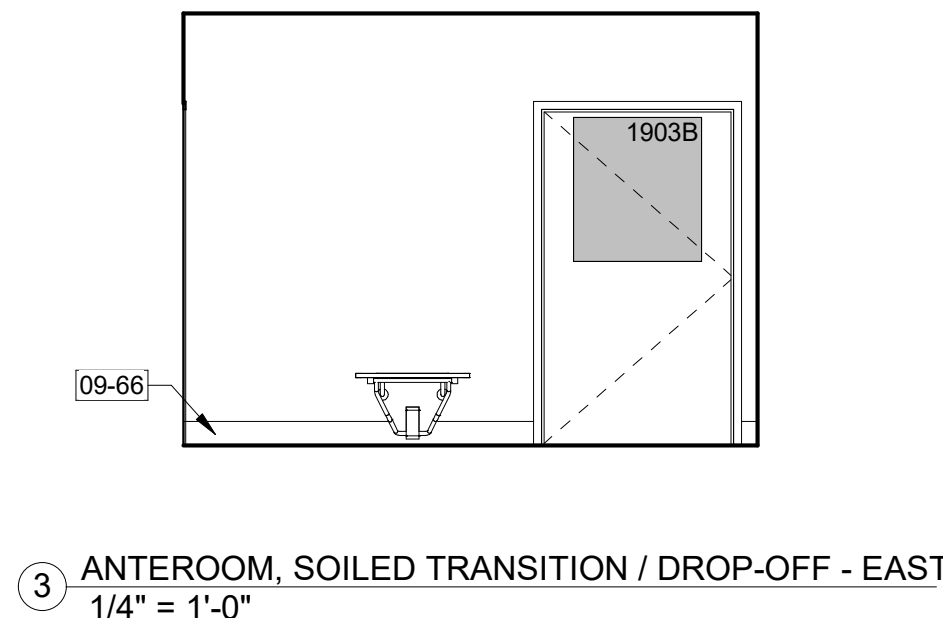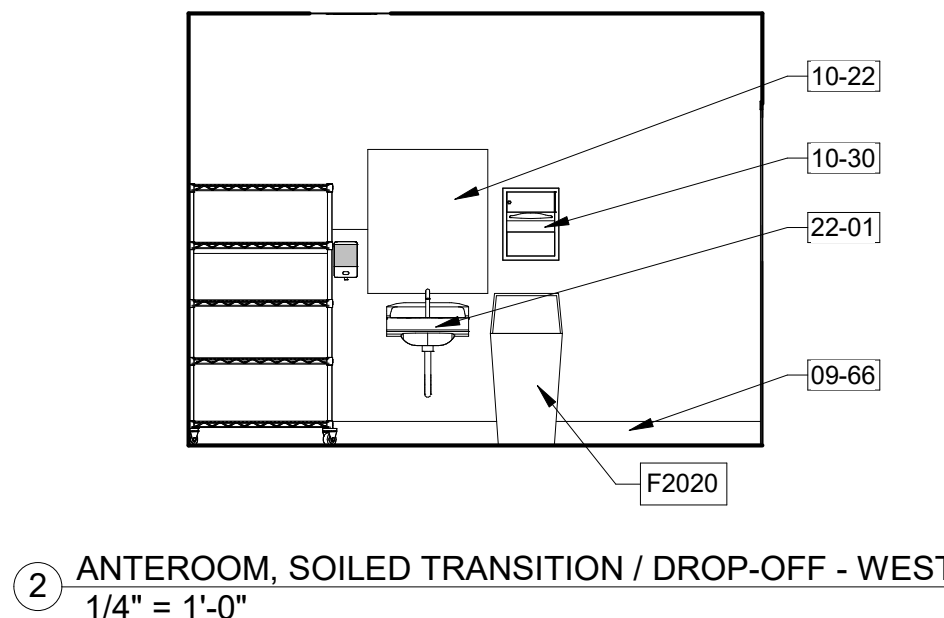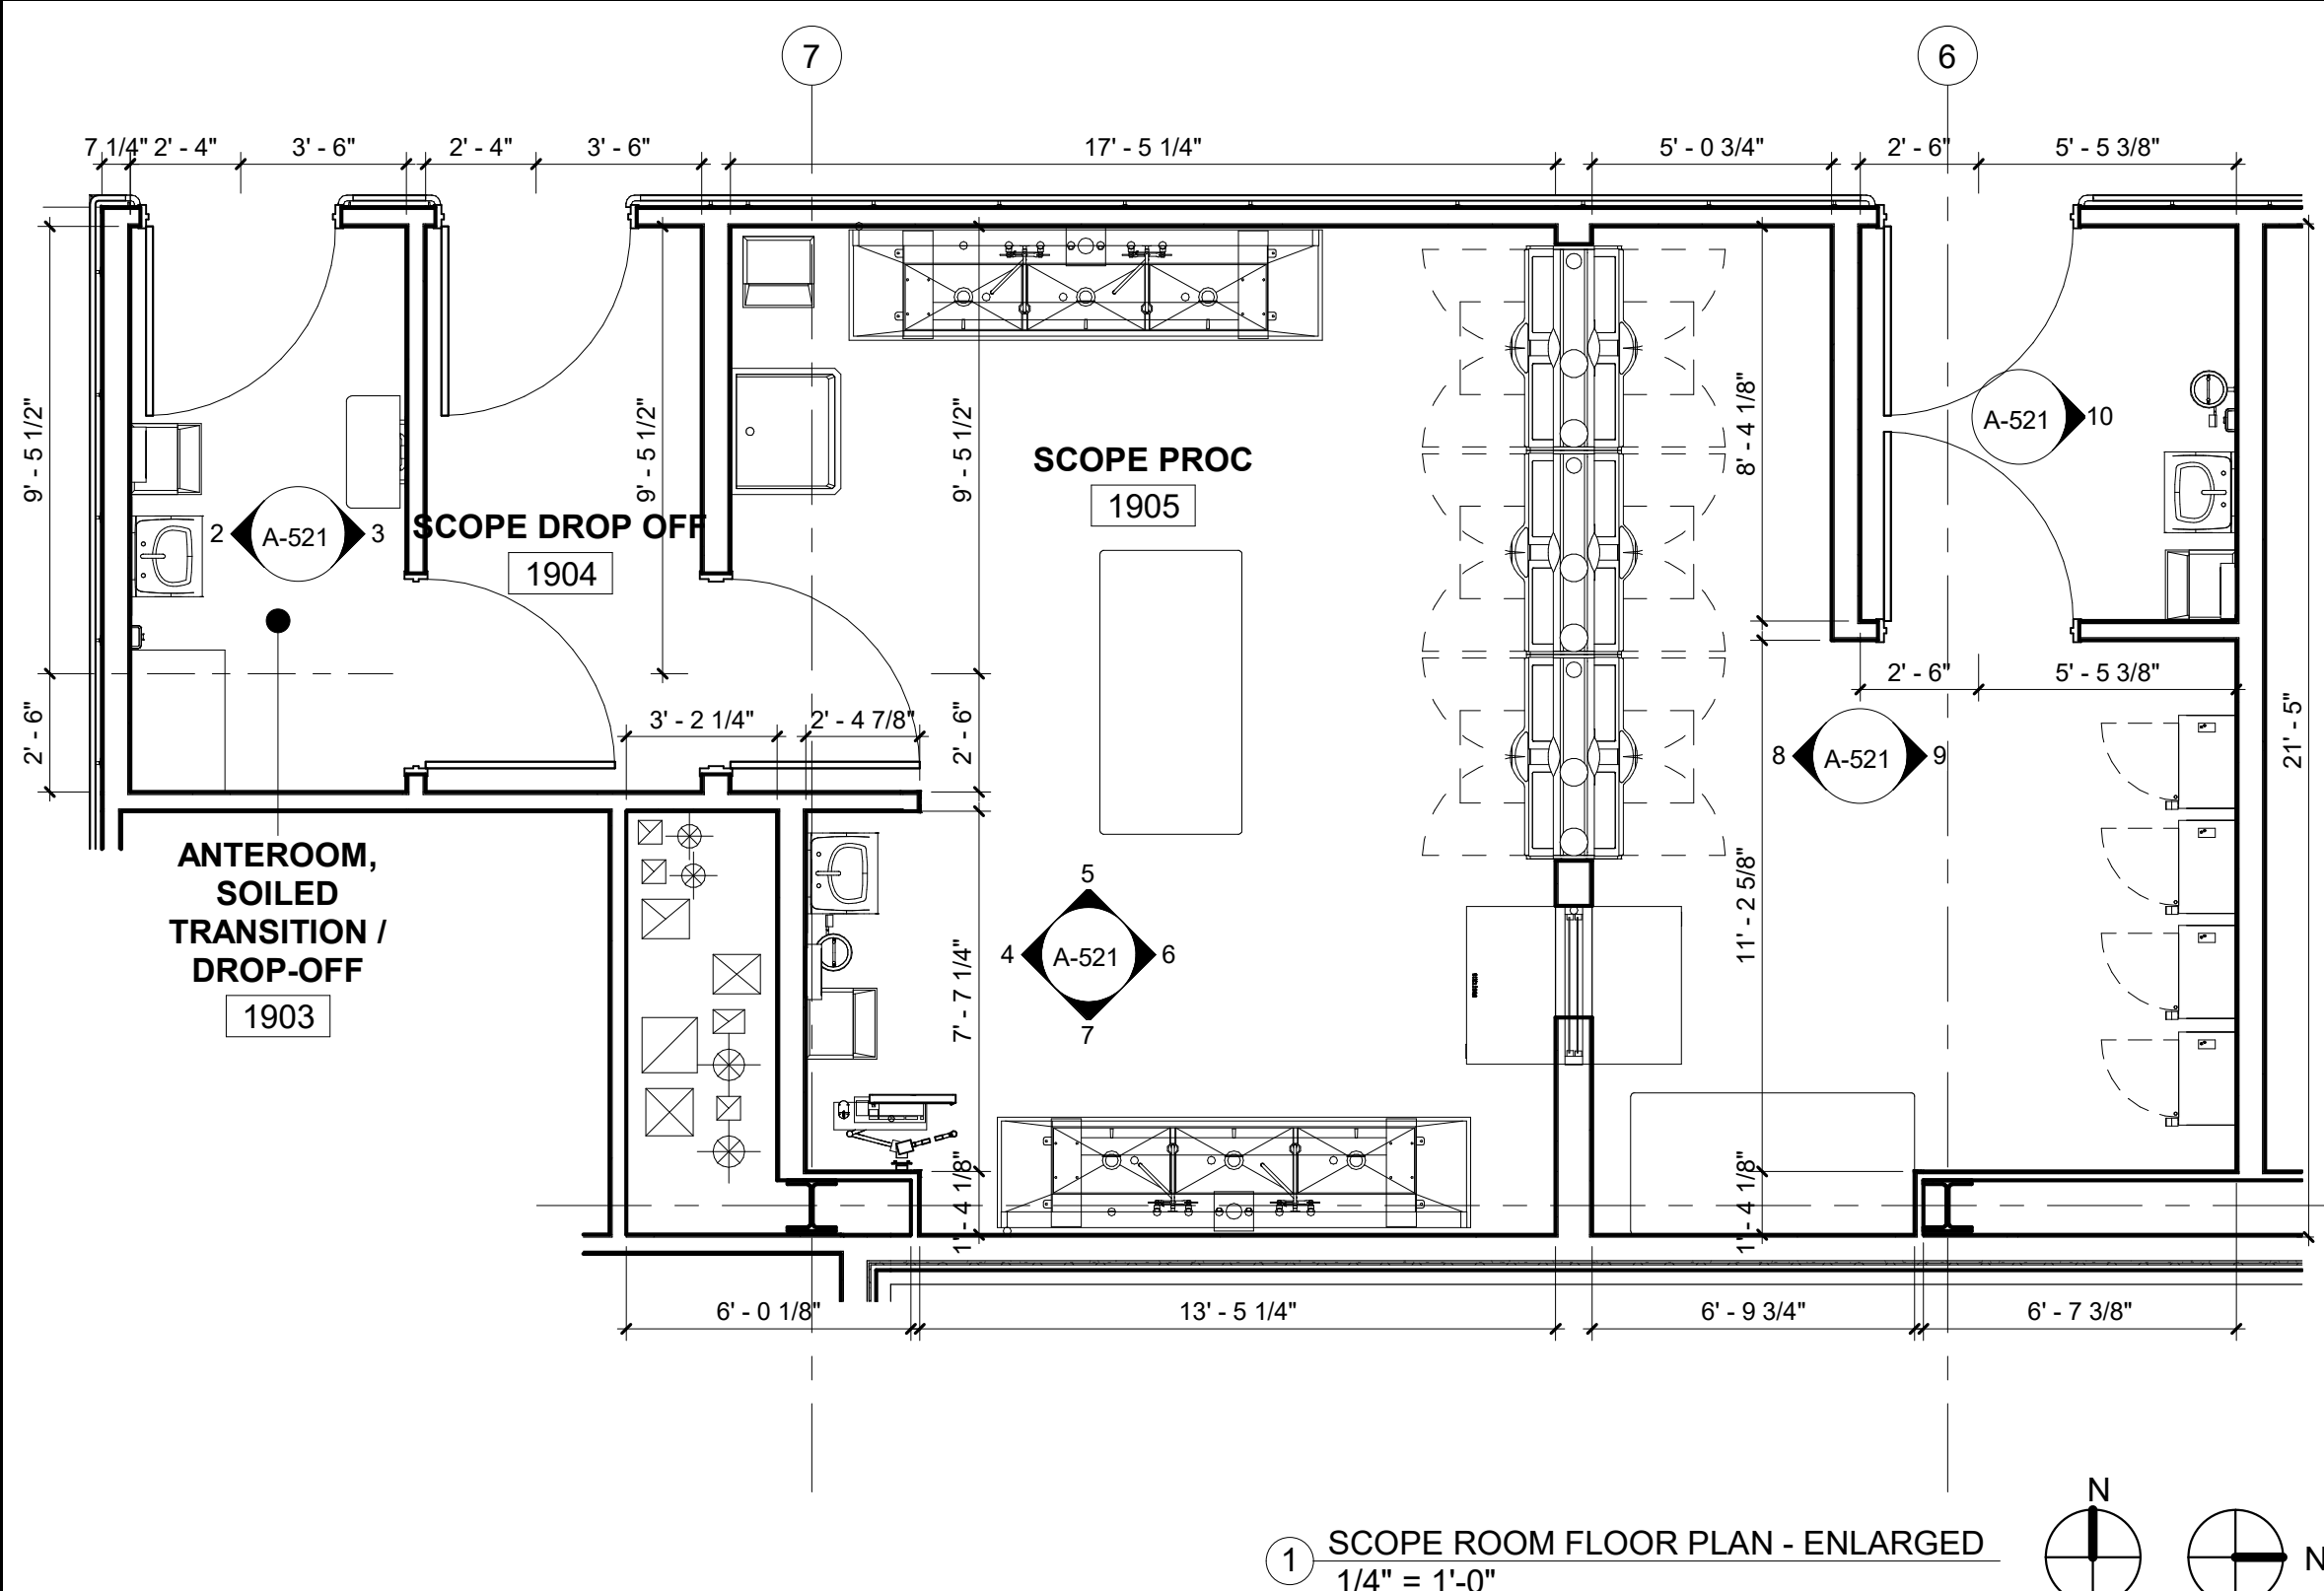

CONSTRUCTION DOCUMENTS

CONSULTANTS:		ARCHITECT		Drawing Title		Project Title		Project Number		Office of Construction and Facilities Management	
 TERRASITE DESIGN 1635 DEADWOOD AVENUE RAPID CITY, SOUTH DAKOTA 57702 PH: (605) 791-1736		 ALBERTSON ENGINEERING, INC. 315 NORTH MAIN AVENUE, SUITE 200 SIOUX FALLS, SOUTH DAKOTA 57104 PH: (605) 274-0880		 FOURFRONT DESIGN, INC. 517 7TH STREET RAPID CITY, SOUTH DAKOTA 57701 PH: (605) 342-9470 FAX: (605) 342-2377 WWW.FOURFRONTDESIGN.COM		ENLARGED PLANS AND INTERIOR ELEVATIONS		Design/Construct Sterile Processing Service- Omaha VA Medical Center		16.2330.A08	
COMPLIANCY REVIEW COMPLETED		FARRIS ENGINEERING 12700 WEST DODGE ROAD OMAHA, NEBRASKA 68154 PH: (402) 330-5900		Approved: Project Director		Location		Building Number		A-521	
Revisions:		Date		Omaha VA Medical Center		4101 Woolworth Ave #4199 Omaha, Ne 68105		Drawing Number		Dwg. 56 of 143	
						Date		Checked		Department of Veterans Affairs	
						11/23/2020		JL JGC			

GENERAL NOTES:


1. SHEET SIZE FOR PROPER SCALE IS 30x42. CONTRACTOR SHALL NOT SCALE DRAWINGS BUT SHALL REQUEST THE DESIRED DIMENSIONS FROM THE ARCHITECT.
2. IT IS THE RESPONSIBILITY OF THE CONTRACTOR TO FIELD VISIT THE PROJECT AND VERIFY EXISTING CONDITIONS, DIMENSIONS AND PROPOSED CONDITIONS. COORDINATE DEMOLITION BETWEEN ALL TRADES. NOTIFY A/E IMMEDIATELY OF ANY CONFLICTS OR DISCREPANCIES.
3. GRID LINES ARE TYPICALLY LOCATED ON THE FACE OF FOUNDATION OR CENTERLINE OF STRUCTURE.
4. WALL PARTITIONS EXTEND TO THE UNDERSIDE OF DECK UNLESS NOTED WITH WALL HEIGHT NEXT TO WALL TYPE TAG.
5. SEE ENLARGED AREA PLANS FOR WALL TYPE INDICATIONS AND DIMENSIONS.
6. SEE CODE PLAN FOR CODE INFORMATION.
7. SEE DIMENSION PLAN FOR DIMENSIONS AND WALL TYPES.
8. EXISTING DOORS SHOW AT 45 DEGREE ANGLE FOR CLARITY WITH THE EXCEPTION OF TOILET PARTITIONS.
9. EXISTING WALL SHADED FOR CLARITY.
10. SYSTEMS FURNISHINGS AND OWNER PROVIDED CONTRACTOR INSTALLED ITEMS NOT SHOWN FOR CLARITY. SEE FF&E PLANS.

SHEET SPECIFIC NOTES:


1. BRING BOTTOM OF CORNER GUARDS 4" AFF.

KEYNOTES:


- 09-45 CORNER GUARD, SEE SPECIFICATION.
09-65 RB-1, RUBBER BASE, SEE SPECIFICATION.
09-66 RES6, EPOXY FLOOR/COVE, SEE SPECIFICATION.
10-22 MIRROR, SEE SPECIFICATION.
10-26 RWC, RIGID VINYL WALL PROTECTION, SEE SPECIFICATION.
10-30 SURFACE MOUNTED PAPER TOWEL DISPENSER, SEE SPECIFICATION.
10-37 SOAP DISPENSER (A5075), VA PROVIDED, CONTRACTOR INSTALLED.
10-40 FIRE EXTINGUISHER CABINET.
11-30 REFRIGERATOR BY OWNER, TYP. (N.I.C. - REF. ELECTRICAL).
12-35 PL-1, PLASTIC LAMINATE WALL CABINETS, TYP., SEE SPECIFICATION.
12-41 QUARTZ COUNTERTOP, EASED EDGE.
12-42 PL-1, PLASTIC LAMINATE WALL CABINETS, TYP., SEE SPECIFICATION.
22-01 PLUMBING FIXTURE (REF. MECHANICAL).
26-02 ELECTRICAL EQUIPMENT (REFERENCE ELECTRICAL).

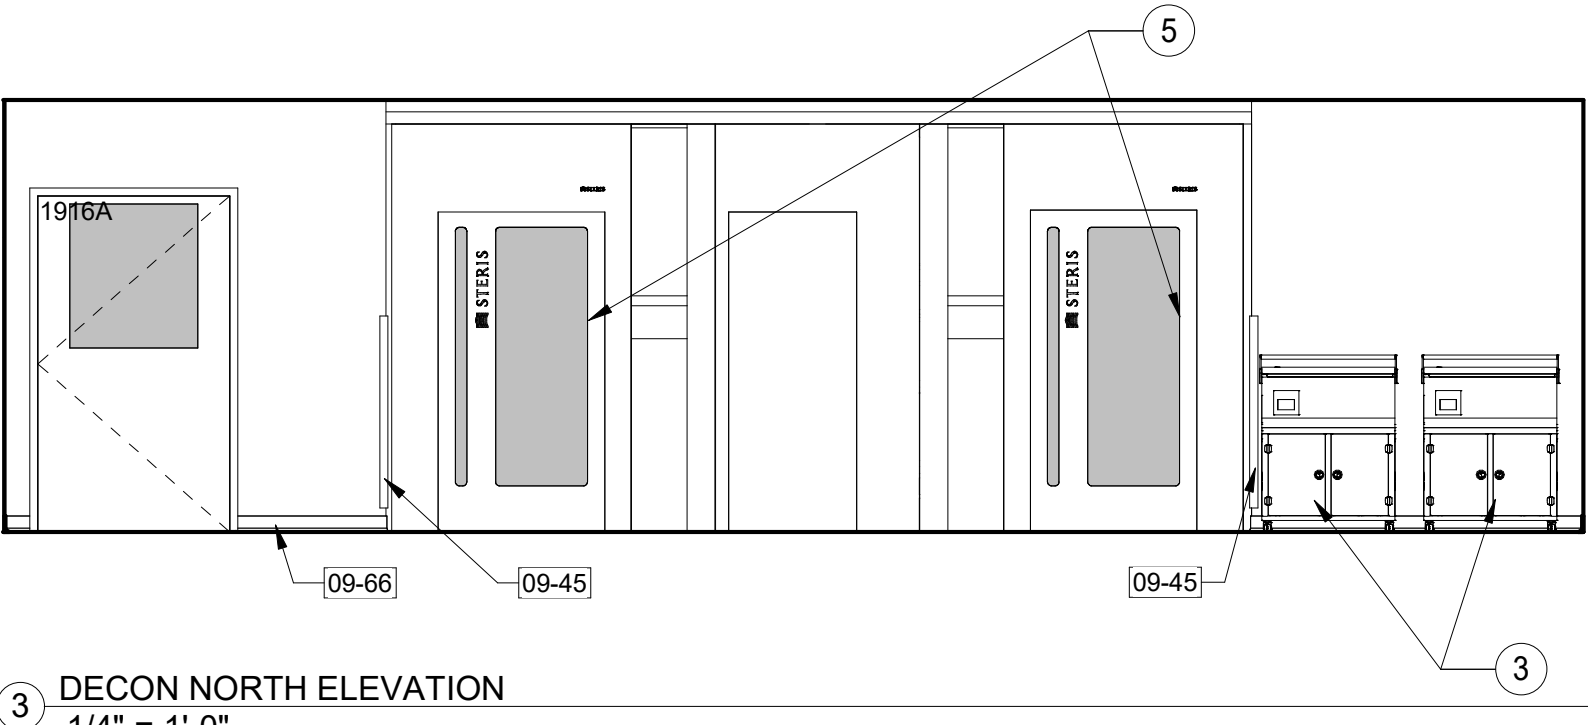


3 DECON NORTH ELEVATION
1/4" = 1'-0"

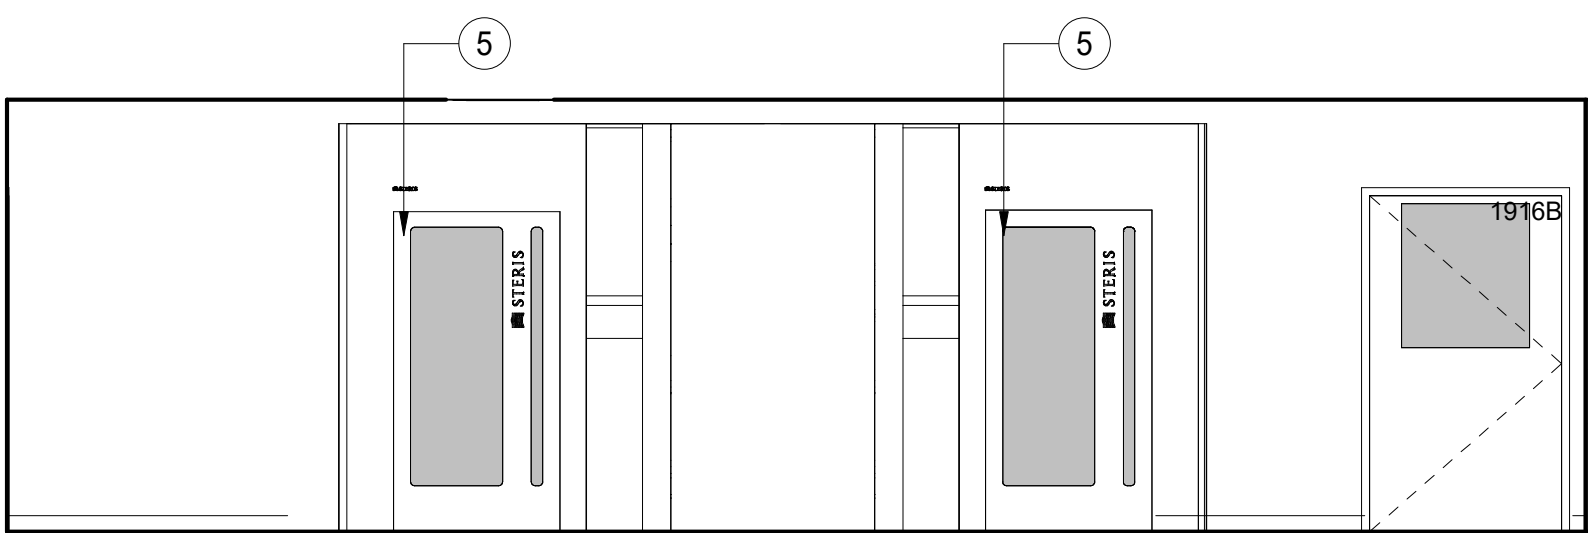


6 CART DRY SOUTH ELEVATION
1/4" = 1'-0"

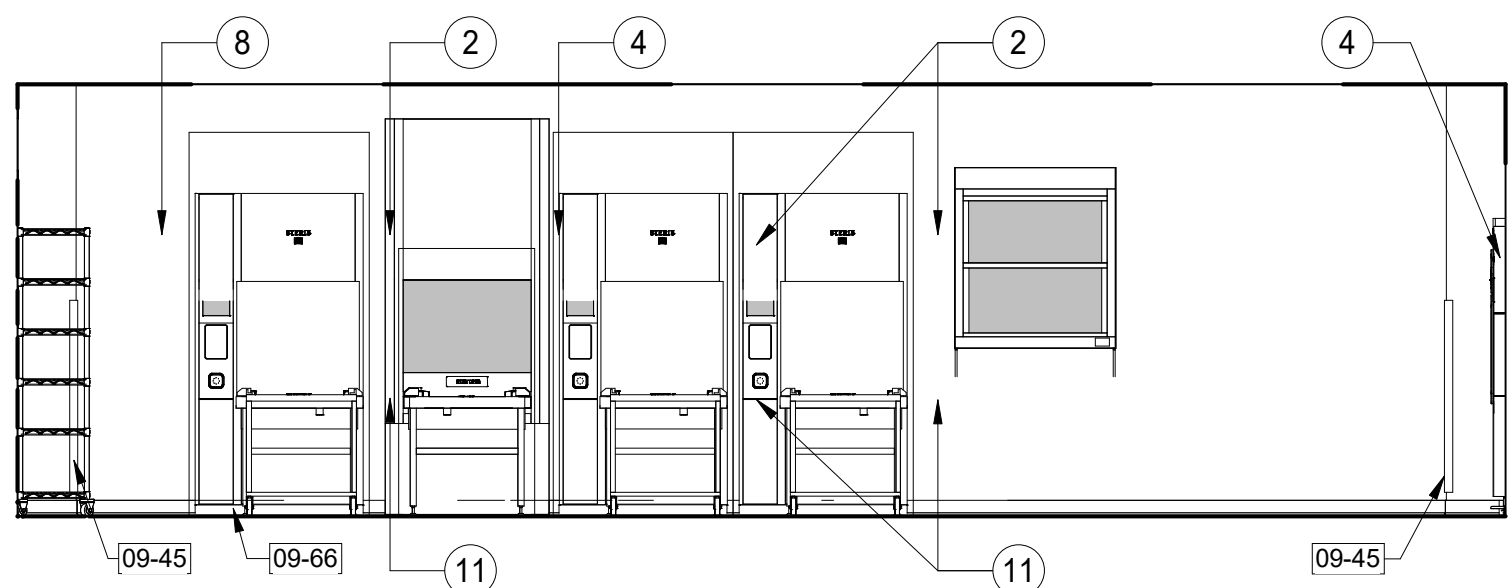


9 PREP ASSEMBLY WEST ELEVATION
1/4" = 1'-0"

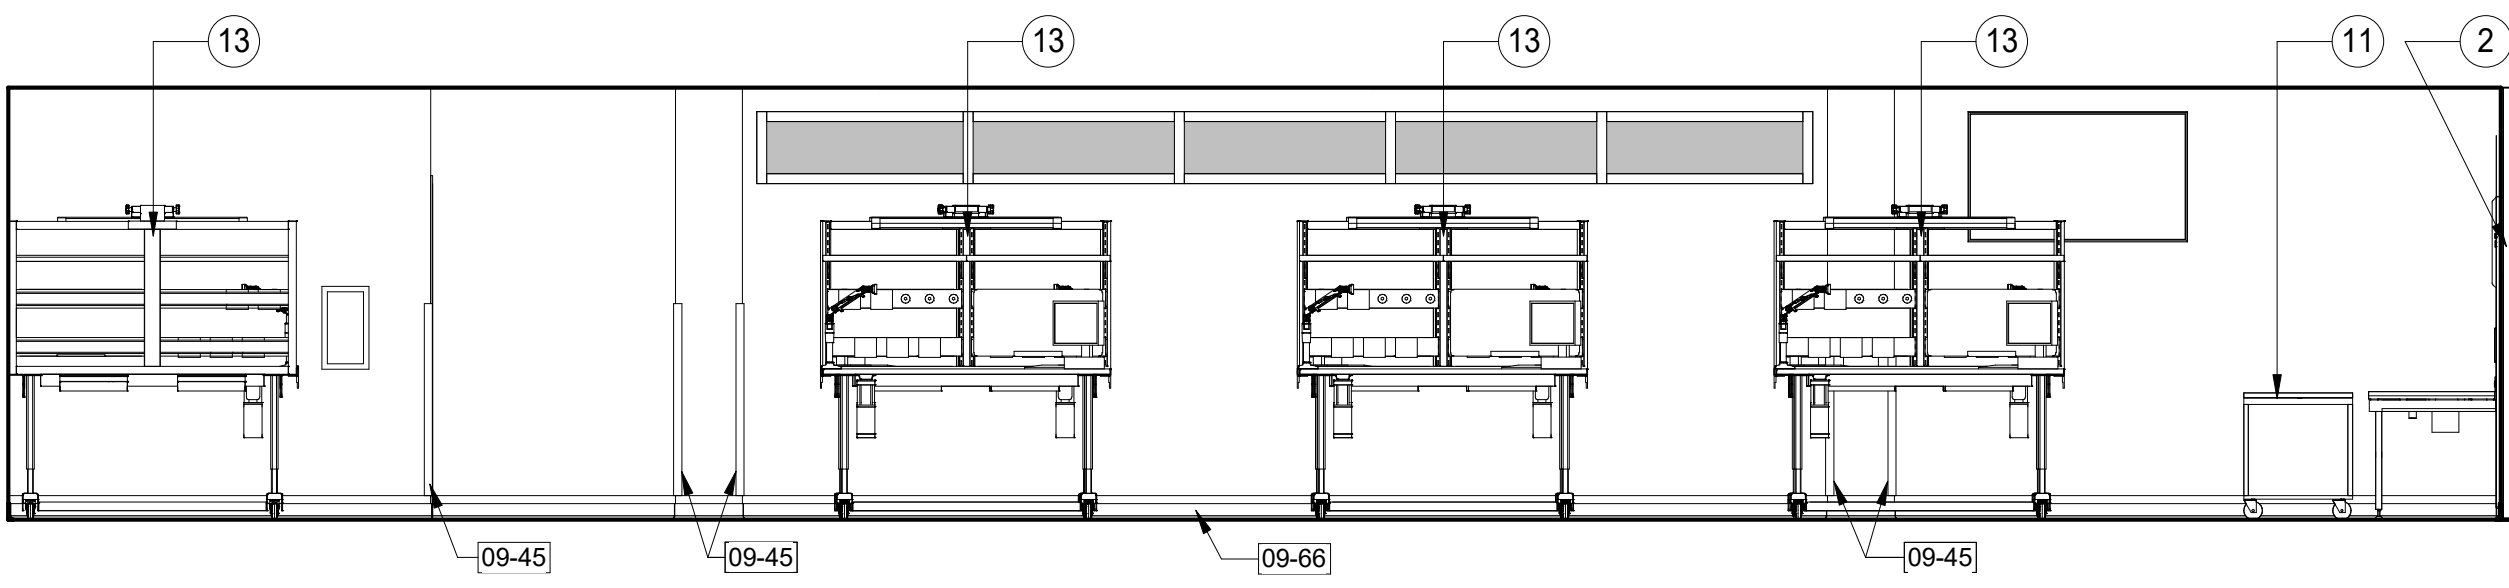


12 PREP ASSEMBLY SOUTH ELEVATION
1/4" = 1'-0"

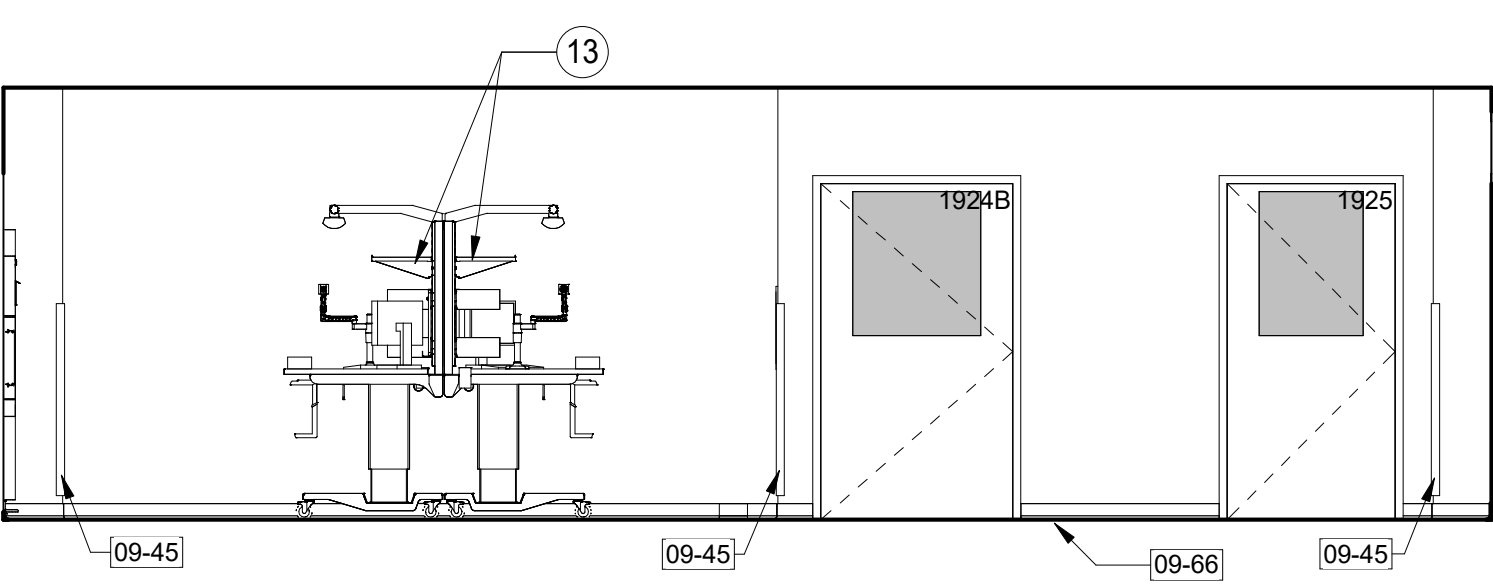


11 PREP ASSEMBLY EAST ELEVATION
1/4" = 1'-0"

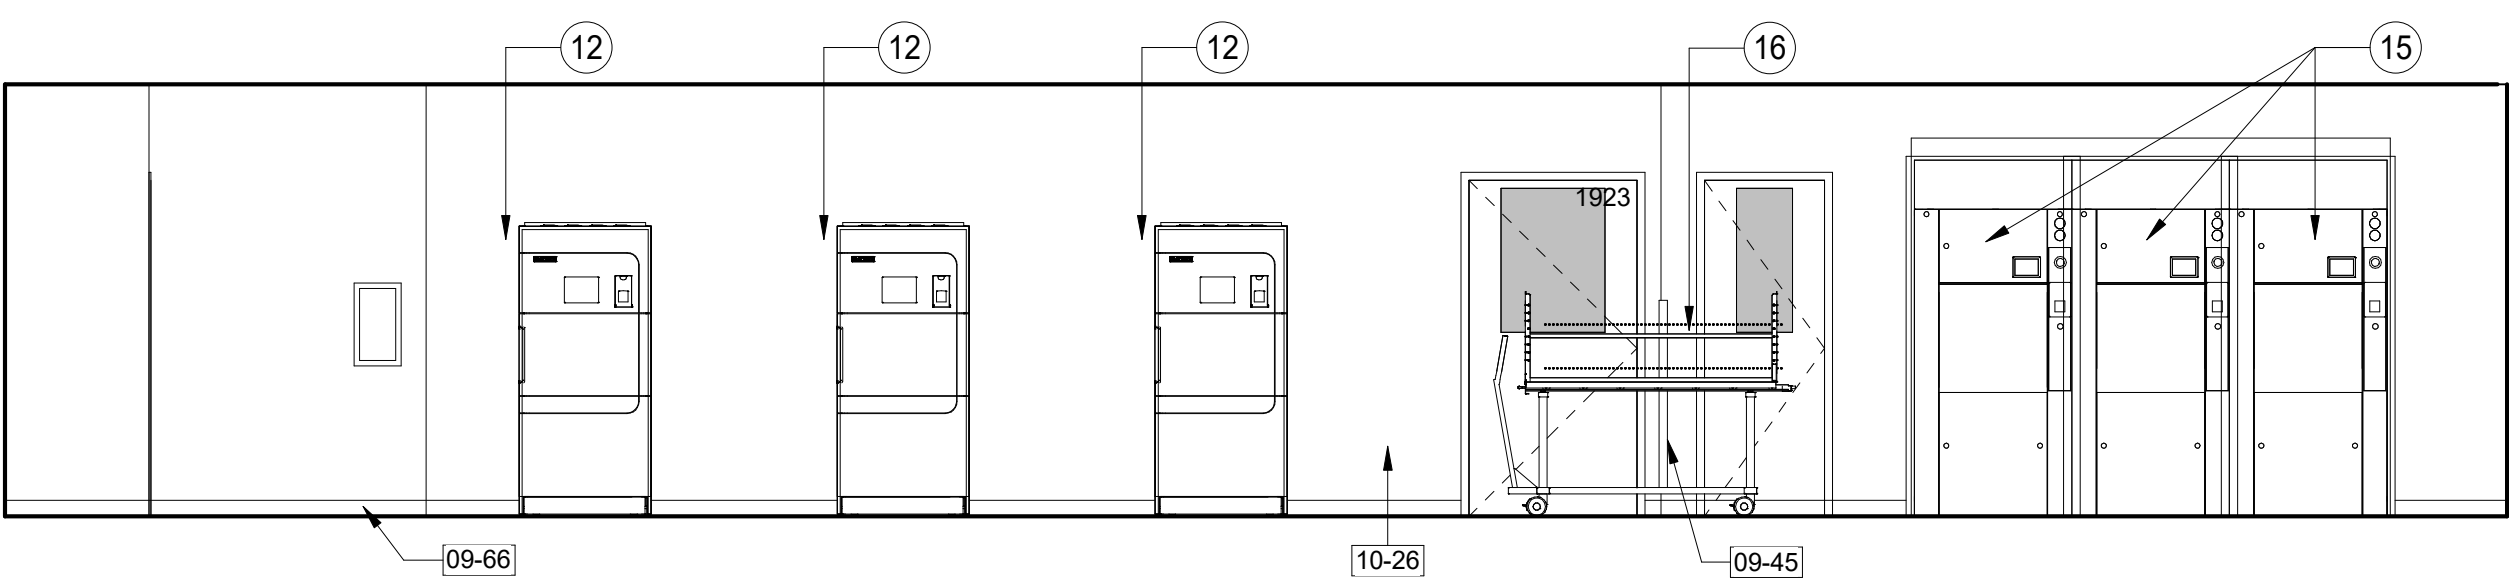


8 STERILIZATION SOUTH ELEVATION
1/4" = 1'-0"

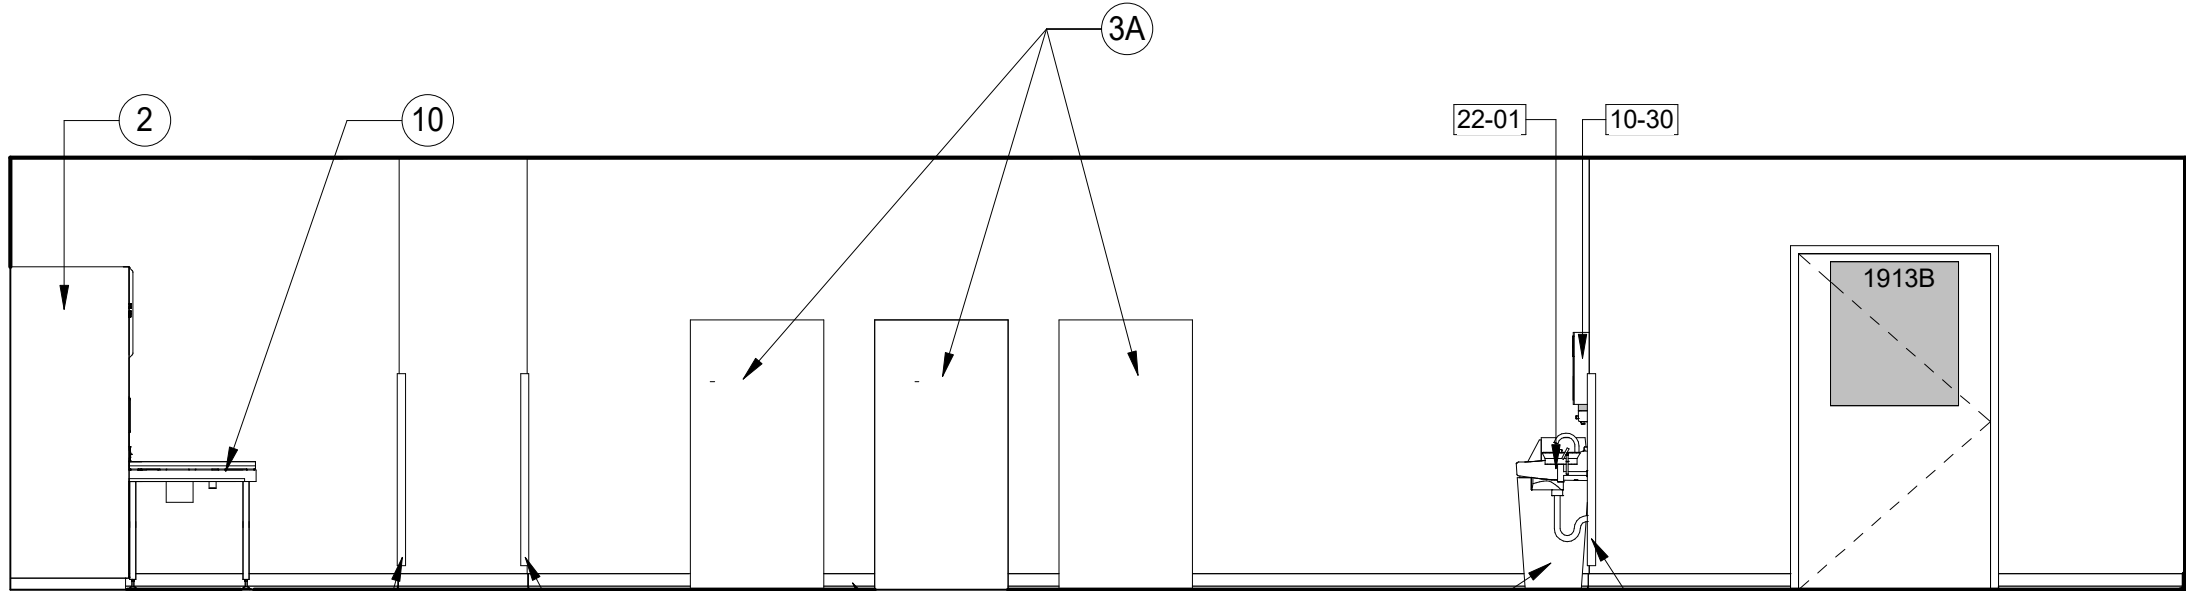


5 DECON SOUTH ELEVATION
1/4" = 1'-0"

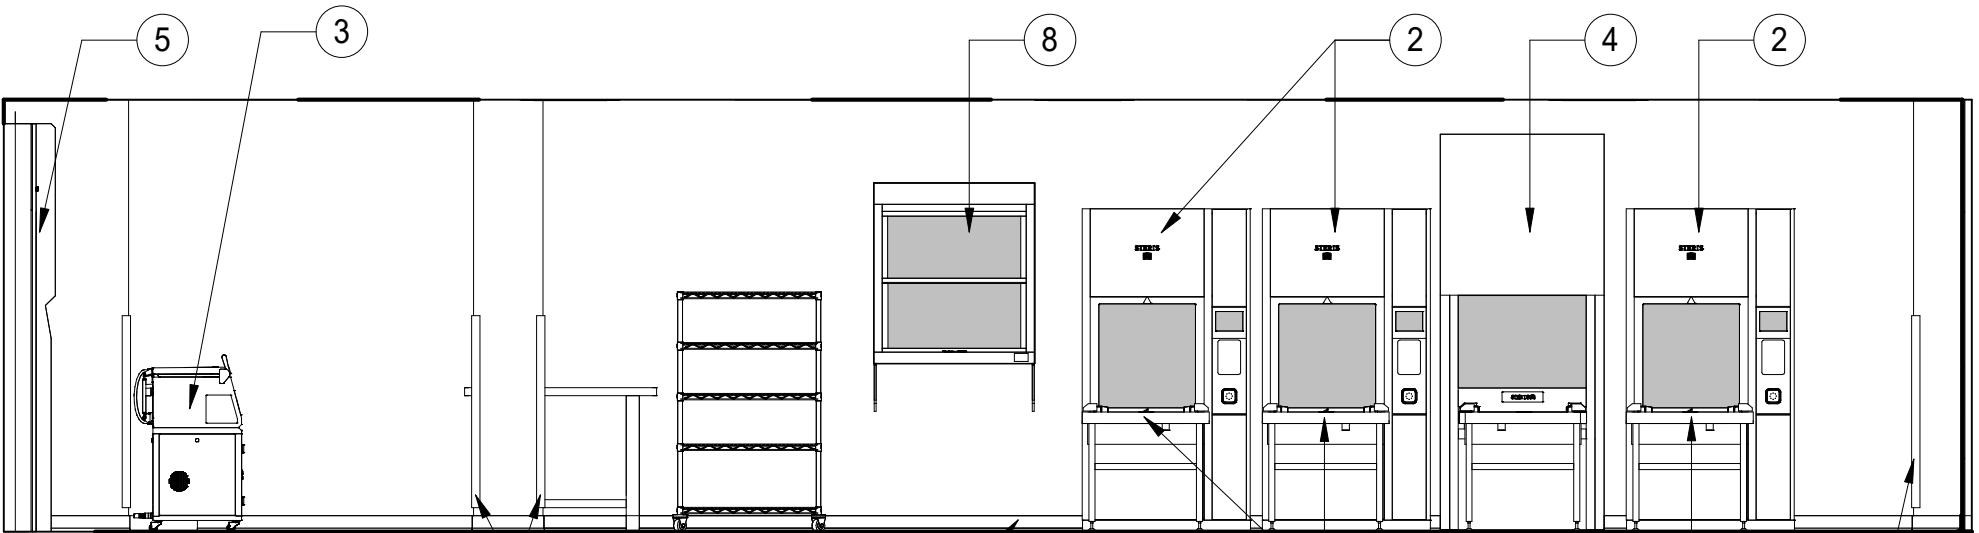


4 DECON EAST ELEVATION
1/4" = 1'-0"

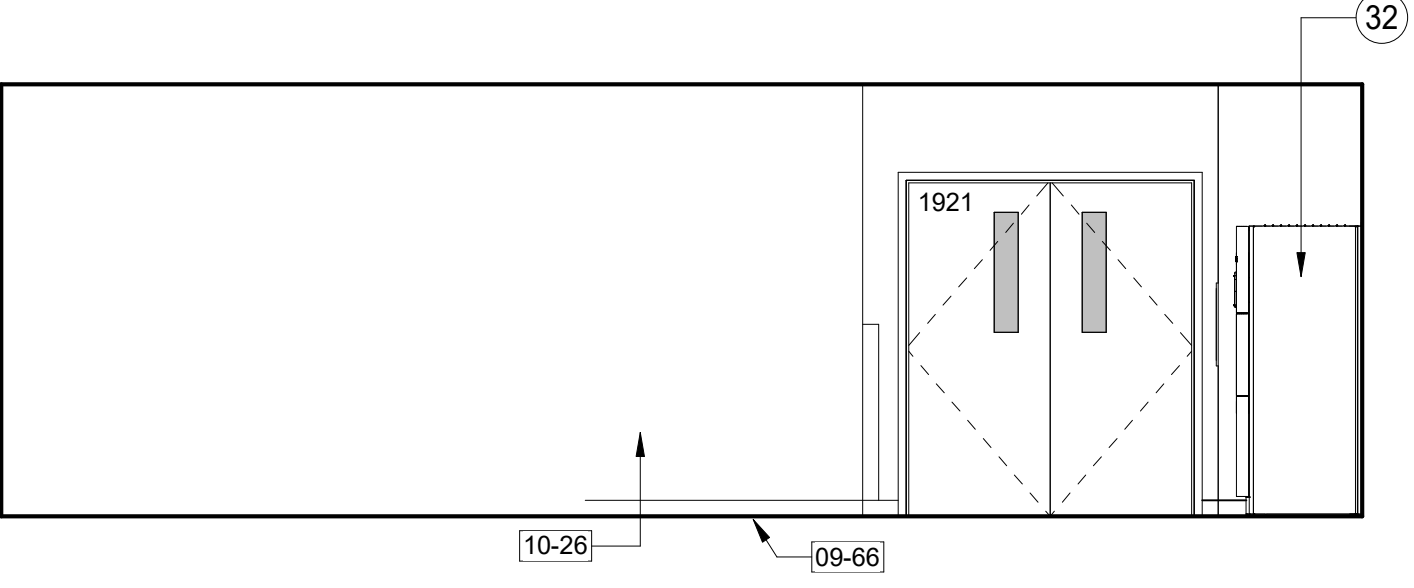


7 STERILIZATION EAST ELEVATION
1/4" = 1'-0"

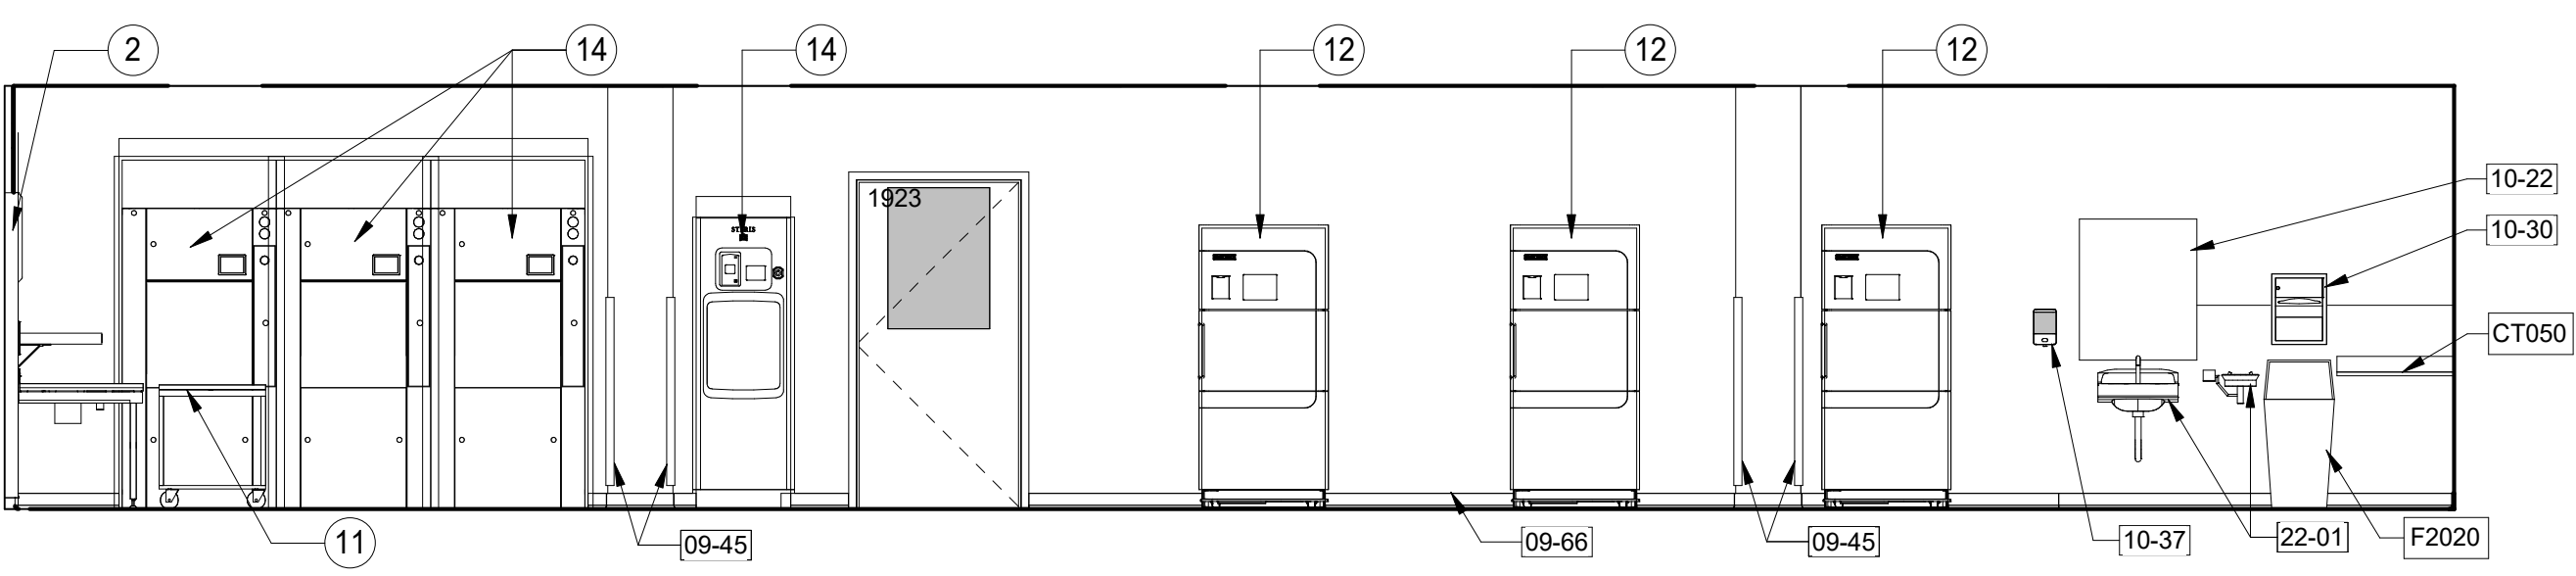

10 PREP ASSEMBLY NORTH ELEVATION
1/4" = 1'-0"

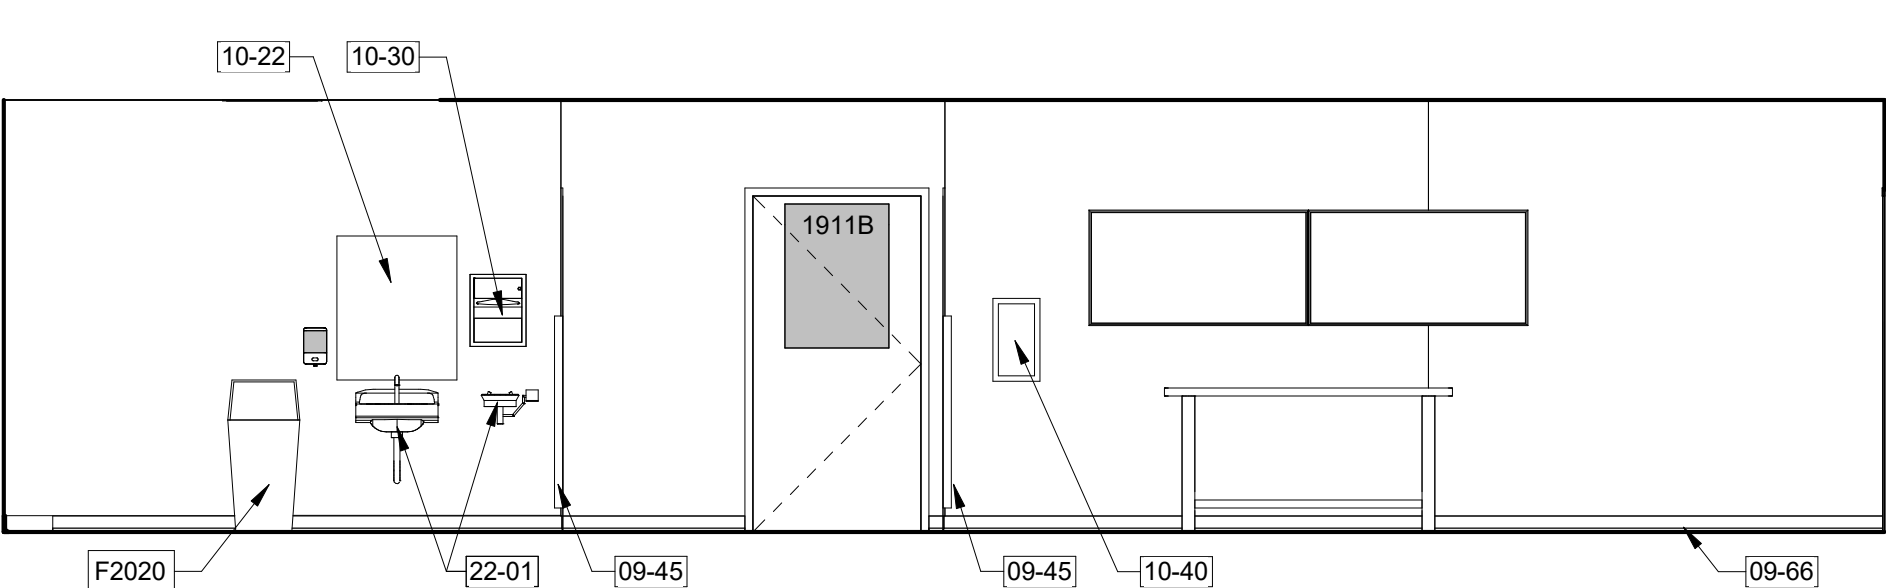

2 DECON WEST ELEVATION
1/4" = 1'-0"


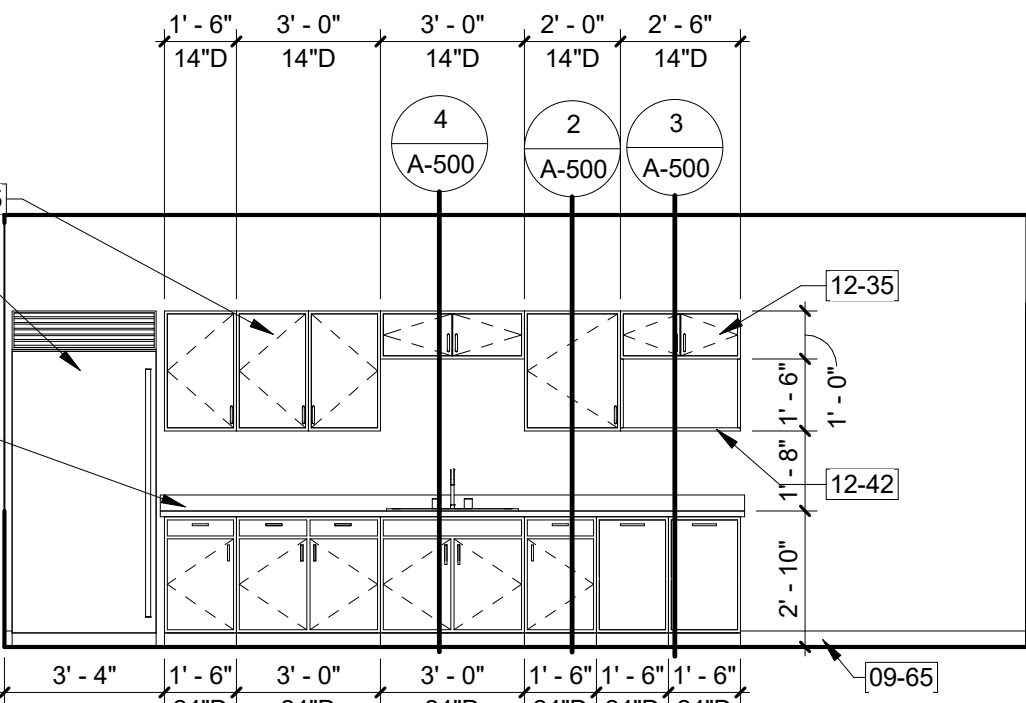


1 BREAK ROOM WEST ELEVATION
1/4" = 1'-0"

CONSTRUCTION DOCUMENTS

CONSULTANTS: TerraSite Design 1635 DEADWOOD AVENUE RAPID CITY, SOUTH DAKOTA 57702 PH: (605) 791-1736 Albertson Engineering Inc. 315 NORTH MAIN AVENUE, SUITE 200 SIOUX FALLS, SOUTH DAKOTA 57104 PH: (605) 274-0880 FARRIS ENGINEERING OMAHA (BRANCH) 30101 COLUMBIA STREET OMAHA, NEBRASKA 68154 PH: (402) 330-5900		ARCHITECT FOURFRONT DESIGN, INC. 517 7TH STREET RAPID CITY, SOUTH DAKOTA 57701 PH: (605) 342-9470 FAX: (605) 342-2377 WWW.FOURFRONTDESIGN.COM		Drawing Title INTERIOR ELEVATIONS Approved: Project Director Omaha VA Medical Center		Project Title Design/Construct Sterile Processing Service- Omaha VA Medical Center Location 4101 Woolworth Ave #4199 Omaha, Ne 68105 Date 11/23/2020 Checked JL Drawn JGC		Project Number 16.2330.A08 Building Number 25 Drawing Number A-522 Dwg. 57 of 143		Office of Construction and Facilities Management Department of Veterans Affairs	
---	--	--	--	---	--	--	--	---	--	---	--

  
Figure 1 illustrates the construction of the H_n sequence of fractal curves, showing the iterative process from H_0 to H_n . The figure consists of two main parts: a top section labeled "one foot" and a bottom section labeled "one half inch = one foot". Each part shows a series of curves labeled H_0, H_1, H_2, H_3, H_4 , with corresponding numerical values below them. The top section shows the construction of H_0 as a straight line segment of length 1, and subsequent curves H_1, H_2, H_3, H_4 as increasingly complex fractal curves. The bottom section shows the construction of H_0 as a straight line segment of length 1/2, and subsequent curves H_1, H_2, H_3, H_4 as increasingly complex fractal curves.



1. SHEET SIZE FOR PROPER SCALE IS 30X42.
2. CONTRACTOR SHALL NOT SCALE DRAWINGS BUT SHALL REQUEST THE DESIRED DIMENSIONS FROM THE ARCHITECT.
3. IT IS THE RESPONSIBILITY OF THE CONTRACTOR TO VISIT THE PROJECT SITE TO VERIFY ALL EXISTING CONDITIONS/DIMENSIONS AND PROPOSED CONDITIONS. COORDINATE DEMOLITION BETWEEN ALL TRADES. NOTIFY ALL AFFECTED TRADES OF ANY CONFLICTS OR DISCREPANCIES.
4. GRIDLINES ARE TYPICALLY LOCATED ON THE FACE OF WALL PARTITIONS OR CORNERS OF WALLS. ALL ACTUAL WALL PARTITIONS EXTEND TO THE UNDERSIDE OF WALL UNLESS NOTED WITH WALL HEIGHT NEXT TO WALL TYPE.
5. SEE ENLARGED AREA PLANS FOR WALL TYPE INDICATIONS AND DIMENSIONS.
6. SEE CODE PLAN FOR DEMOLITION INFORMATION.
7. SEE DIMENSION PLAN FOR DIMENSIONS AND WALL PARTITIONS.
8. EXISTING DOORS SHOW AT 45 DEGREE ANGLE FOR CLARITY WITH THE EXCEPTION OF TOILET PARTITIONS.
9. EXISTING WALL SHADED FOR CLARITY.
10. SYSTEMS FURNISHINGS AND OWNER PROVIDED CONTRACTOR INSTALLED ITEMS NOT SHOWN FOR CLARITY. SEE FF&E PLANS.





1. SEE SPECIFICATIONS FOR FINISHES AND BASIS OF DESIGN OMAHA VA SIGN STANDARDS
2. WHERE PERMANENT IDENTIFICATION IS PROVIDED FOR ROOMS AND SPACES, SIGNS SHALL BE INSTALLED ON THE WALL ADJACENT TO THE LATCH SIDE OF THE DOOR, WHERE THERE IS NO WALL SPACE TO THE LATCH SIDE OF THE DOOR, INCLUDING AT DOUBLE LEAF DOORS, SIGNS SHALL BE PLACED ON THE NEAREST ADJACENT WALL. MOUNTING HEIGHT SHALL BE 625 MM ABOVE THE FINISH FLOOR TO THE CENTERLINE OF THE SIGN. WALL MOUNTED TYPE H AND I SIGNS TO BE MOUNTED 80" AFF TO BOTTOM OF SIGN.

DOOR SCHEDULE												
MARK	ROOM	FIRE RATING	WIDTH	HEIGHT	PANEL TYPE	GLAZING TYPE	FRAME TYPE	HEAD	JAMB	SILL	HARDWARE GROUP	COMMENTS
1802A	ELECTRICAL	-	4' - 0"	7' - 0"	WD-F	-	HM-001	1/A-600	2/A-600	--	HW-4	
1802B	ELECTRICAL	-	4' - 0"	7' - 0"	WD-F	-	HM-001	1/A-600	2/A-600	--	HW-4	
1802C	ELECTRICAL	45 MIN	4' - 0"	7' - 0"	WD-F	-	HM-001	1/A-600	2/A-600	--	HW-4	
1802D	ELECTRICAL	45 MIN	4' - 0"	7' - 0"	WD-F	-	HM-001	1/A-600	2/A-600	--	HW-4	
1803	STAIRS	90 MIN	6' - 0"	7' - 0"	WD-F	-	HM-001	3/A-600	4/A-600	--	HW-5	
1803A	STAIRS	90 MIN	6' - 0"	7' - 0"	HM-F	-	HM-001	9/A-600	10/A-600	11/A-600	HW-1	FOUR SIDED DOOR FRAME, FULL DEPTH OF OPENING, MASONRY HEAD
1803B	STAIRS	90 MIN	6' - 0"	7' - 0"	HM-F	-	HM-001	9/A-600	10/A-600	11/A-600	HW-1	FOUR SIDED DOOR FRAME, FULL DEPTH OF OPENING, MASONRY HEAD
1901	OPEN SPACE	-	4' - 0"	7' - 0"	HM-F	-	HM-001	1/A-600	2/A-600	--	HW-14	
1902	IT	45 MIN/SMOKE	4' - 0"	7' - 0"	HM-F	-	HM-001	1/A-600	2/A-600	--	HW-7	COORDINATE CARD READER; RE: SPEC AND ELECTRICAL
1903A	ANTEROOM, SOILED TRANSITION / DROP-OFF	SMOKE	4' - 0"	7' - 0"	WD-HG	T	HM-001	1/A-600	2/A-600	--	HW-14	
1903B	ANTEROOM, SOILED TRANSITION / DROP-OFF	-	4' - 0"	7' - 0"	WD-HG	T	FRP-001	1/A-600	2/A-600	--	HW-14	
1904A	SCOPE DROP OFF	SMOKE	4' - 0"	7' - 0"	WD-HG	T	HM-001	1/A-600	2/A-600	--	HW-10	COORDINATE AUTO DOOR OPENER; RE: SPEC AND ELECTRICAL
1904B	SCOPE DROP OFF	-	4' - 0"	7' - 0"	WD-HG	T	FRP-001	1/A-600	2/A-600	--	HW-11	COORDINATE AUTO DOOR OPENER; RE: SPEC AND ELECTRICAL
1906A	SCOPE ANTE	SMOKE	4' - 0"	7' - 0"	WD-HG	T	HM-001	1/A-600	2/A-600	--	HW-14	COORDINATE AUTO DOOR OPENER; RE: SPEC AND ELECTRICAL
1906B	SCOPE ANTE	-	4' - 0"	7' - 0"	WD-HG	T	HM-001	1/A-600	2/A-600	--	HW-20	COORDINATE AUTO DOOR OPENER; RE: SPEC AND ELECTRICAL
1907	WOMEN'S LOCKER	-	3' - 6"	7' - 0"	WD-F	-	HM-001	1/A-600	2/A-600	--	HW-12	
1907A	WOMEN'S RR	-	3' - 6"	7' - 0"	WD-F	-	HM-001	1/A-600	2/A-600	--	HW-21	COORDINATE AUTO DOOR OPENER; RE: SPEC AND ELECTRICAL
1907B	WOMEN'S RR	-	3' - 6"	7' - 0"	WD-F	-	HM-001	1/A-600	2/A-600	--	HW-22	
1907C	WOMEN'S SHOWER	-	3' - 6"	7' - 0"	WD-F	-	HM-001	1/A-600	2/A-600	--	HW-21	
1908	MEN'S LOCKER	-	3' - 6"	7' - 0"	WD-F	-	HM-001	1/A-600	2/A-600	--	HW-12	
1908A	MEN'S RR	-	3' - 6"	7' - 0"	WD-F	-	HM-001	1/A-600	2/A-600	--	HW-21	COORDINATE AUTO DOOR OPENER; RE: SPEC AND ELECTRICAL
1908B	MEN'S RR	-	3' - 6"	7' - 0"	WD-F	-	HM-001	1/A-600	2/A-600	--	HW-22	
1908C	MEN'S SHOWER	-	3' - 6"	7' - 0"	WD-F	-	HM-001	1/A-600	2/A-600	--	HW-21	
1909	BREAK ROOM	-	3' - 6"	7' - 0"	WD-HG	T	HM-001	1/A-600	2/A-600	--	HW-18	
1910	OPEN OFFICE/TRAINING	-	3' - 0"	7' - 0"	WD-NV	T	HM-001	1/A-600	2/A-600	--	HW-14	
1911A	ANTE VENDOR DROP OFF	SMOKE	3' - 6"	7' - 0"	WD-HG	T	HM-001	1/A-600	2/A-600	--	HW-14	
1911B	ANTE VENDOR DROP OFF	-	3' - 6"	7' - 0"	FRP-HG	T	FRP-001	1/A-600	2/A-600	--	HW-14	
1912	H2O	-	3' - 6"	7' - 0"	WD-F	-	HM-001	1/A-600	2/A-600	--	HW-8	
1913A	CART PASS	SMOKE	3' - 6"	7' - 0"	WD-HG	T	HM-001	1/A-600	2/A-600	--	HW-10	COORDINATE AUTO DOOR OPENER; RE: SPEC AND ELECTRICAL
1913B	CART PASS	-	4' - 0"	7' - 0"	FRP-HG	T	FRP-001	1/A-600	2/A-600	--	HW-11	COORDINATE AUTO DOOR OPENER; RE: SPEC AND ELECTRICAL
1914	HAC	-	3' - 6"	7' - 0"	FRP-F	-	FRP-001	1/A-600	2/A-600	--	HW-7	
1916A	MANUAL CART WASH	-	4' - 0"	7' - 0"	FRP-F	T	FRP-001	1/A-600	2/A-600	--	HW-13	
1916B	MANUAL CART WASH	-	4' - 0"	7' - 0"	FRP-F	T	FRP-001	1/A-600	2/A-600	--	HW-13	
1919	CART DRY	-	4' - 0"	7' - 0"	FRP-HG	T	FRP-001	1/A-600	2/A-600	--	HW-13	COORDINATE AUTO DOOR OPENER; RE: SPEC AND ELECTRICAL
1920	STERILIZATION	-	2' - 6"	7' - 0"	FRP-F	-	FRP-001	1/A-600	2/A-600	--	HW-19	
1921	STERILE STG	SMOKE	6' - 0"	7' - 0"	WD-NV	T	HM-001	1/A-600	2/A-600	--	HW-9	COORDINATE AUTO DOOR OPENER; RE: SPEC AND ELECTRICAL
1923	PREP ASSEMBLY	-	3' - 6"	7' - 0"	FRP-HG	T	FRP-001	1/A-600	2/A-600	--	HW-11	COORDINATE AUTO DOOR OPENER; RE: SPEC AND ELECTRICAL
1924A	ANTE	SMOKE	4' - 0"	7' - 0"	WD-HG	T	HM-001	1/A-600	2/A-600	--	HW-10	COORDINATE AUTO DOOR OPENER; RE: SPEC AND ELECTRICAL
1924B	ANTE	-	4' - 0"	7' - 0"	FRP-HG	T	FRP-001	1/A-600	2/A-600	--	HW-11	COORDINATE AUTO DOOR OPENER; RE: SPEC AND ELECTRICAL
1925	HAC	-	3' - 6"	7' - 0"	FRP-F	-	FRP-001	1/A-600	2/A-600	--	HW-7	
1926	CONFERENCE	-	3' - 0"	7' - 0"	WD-NV	T	HM-001	1/A-600	2/A-600	--	HW-15	
1927	OPEN OFFICE	-	3' - 0"	7' - 0"	WD-F	-	HM-001	1/A-600	2/A-600	--	HW-15	
1928	OFFICE	-	3' - 0"	7' - 0"	WD-F	-	HM-001	1/A-600	2/A-600	--	HW-16	
1929	OFFICE	-	3' - 0"	7' - 0"	WD-F	-	HM-001	1/A-600	2/A-600	--	HW-16	
1930	COPIER ROOM	-	3' - 0"	7' - 0"	WD-F	-	HM-001	1/A-600	2/A-600	--	HW-17	
1931	STAIRS	90 MIN	4' - 0"	7' - 0"	WD-F	-	HM-001	1/A-600	2/A-600	--	HW-3	COORDINATE CARD READER; RE: SPEC AND ELECTRICAL
C4	CORRIDOR	-	6' - 0"	7' - 0"	HM-F	-	HM-001	5/A-600	6/A-600	7/A-600	HW-1	FOUR SIDED DOOR FRAME, FULL DEPTH OF OPENING, MASONRY HEAD
C50	CORRIDOR	-	6' - 0"	7' - 0"	WD-NV	T	HM-001	1/A-600	2/A-600	--	HW-2	COORDINATE CARD READER; RE: SPEC AND ELECTRICAL
H25N	CORRIDOR	90 MIN	6' - 0"	7' - 0"	WD-F	-	HM-001	5/A-600	6/A-600	--	HW-6	

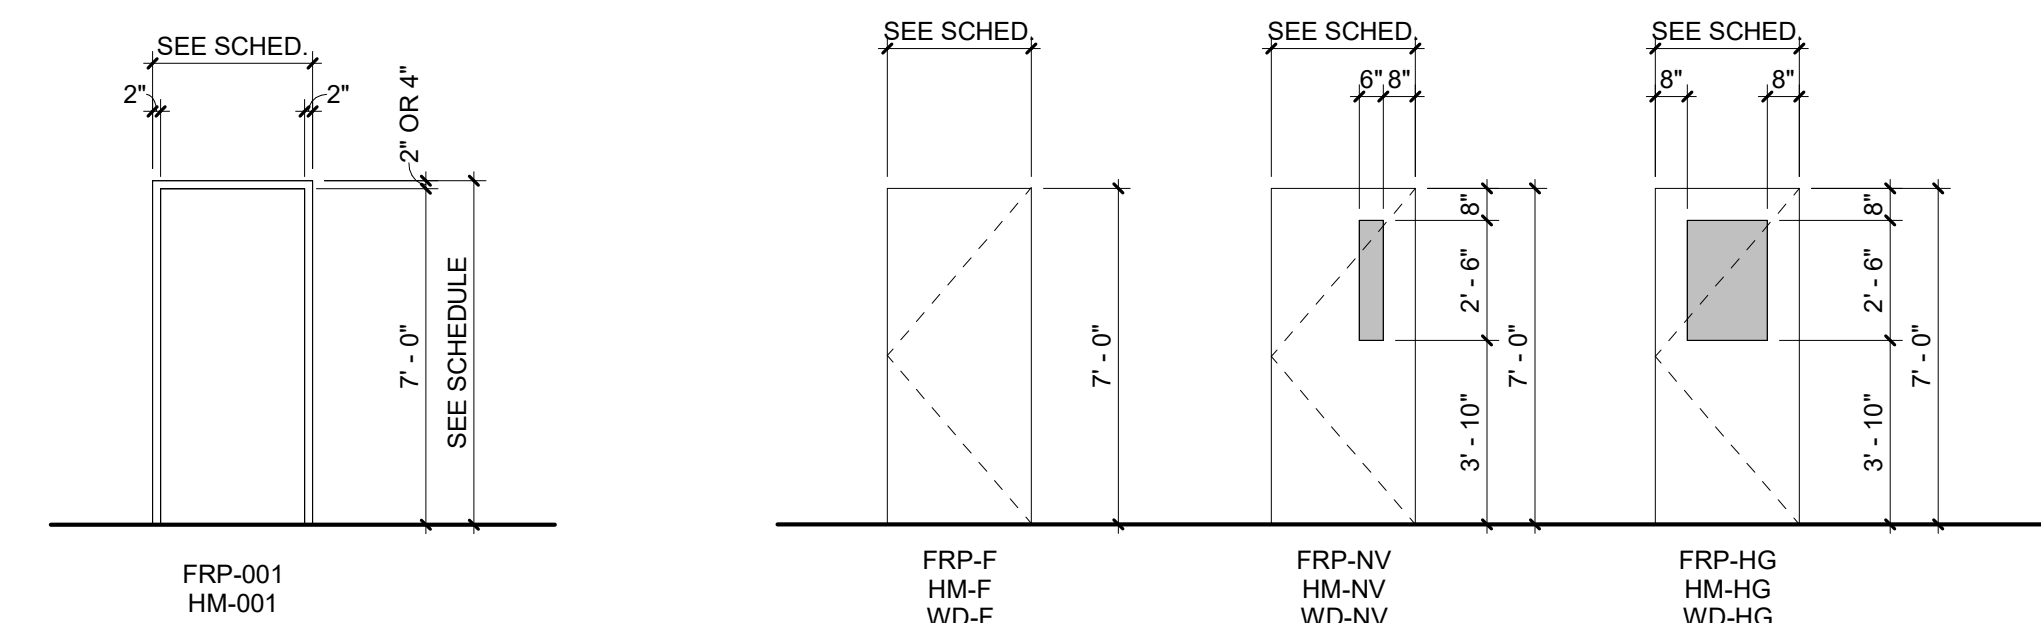

DOOR LEGEND:	
FRP	FIBERGLASS
FRP-F	FIBERGLASS - FLUSH FULL
FRP-HG	FIBERGLASS - HALF GLASS
FRP-NV	FIBERGLASS - NARROW VISION
HM	HOLLOW METAL - FLUSH FULL
HM-F	HOLLOW METAL - HALF GLASS
HM-HG	HOLLOW METAL - NARROW VISION
HM-NV	HOLLOW METAL - NARROW VISION
WD-F	WOOD - FLUSH FULL
WD-HG	WOOD - HALF GLASS
WD-NV	WOOD - NARROW VISION

GLAZING LEGEND:	
T	TEMPERED GLASS

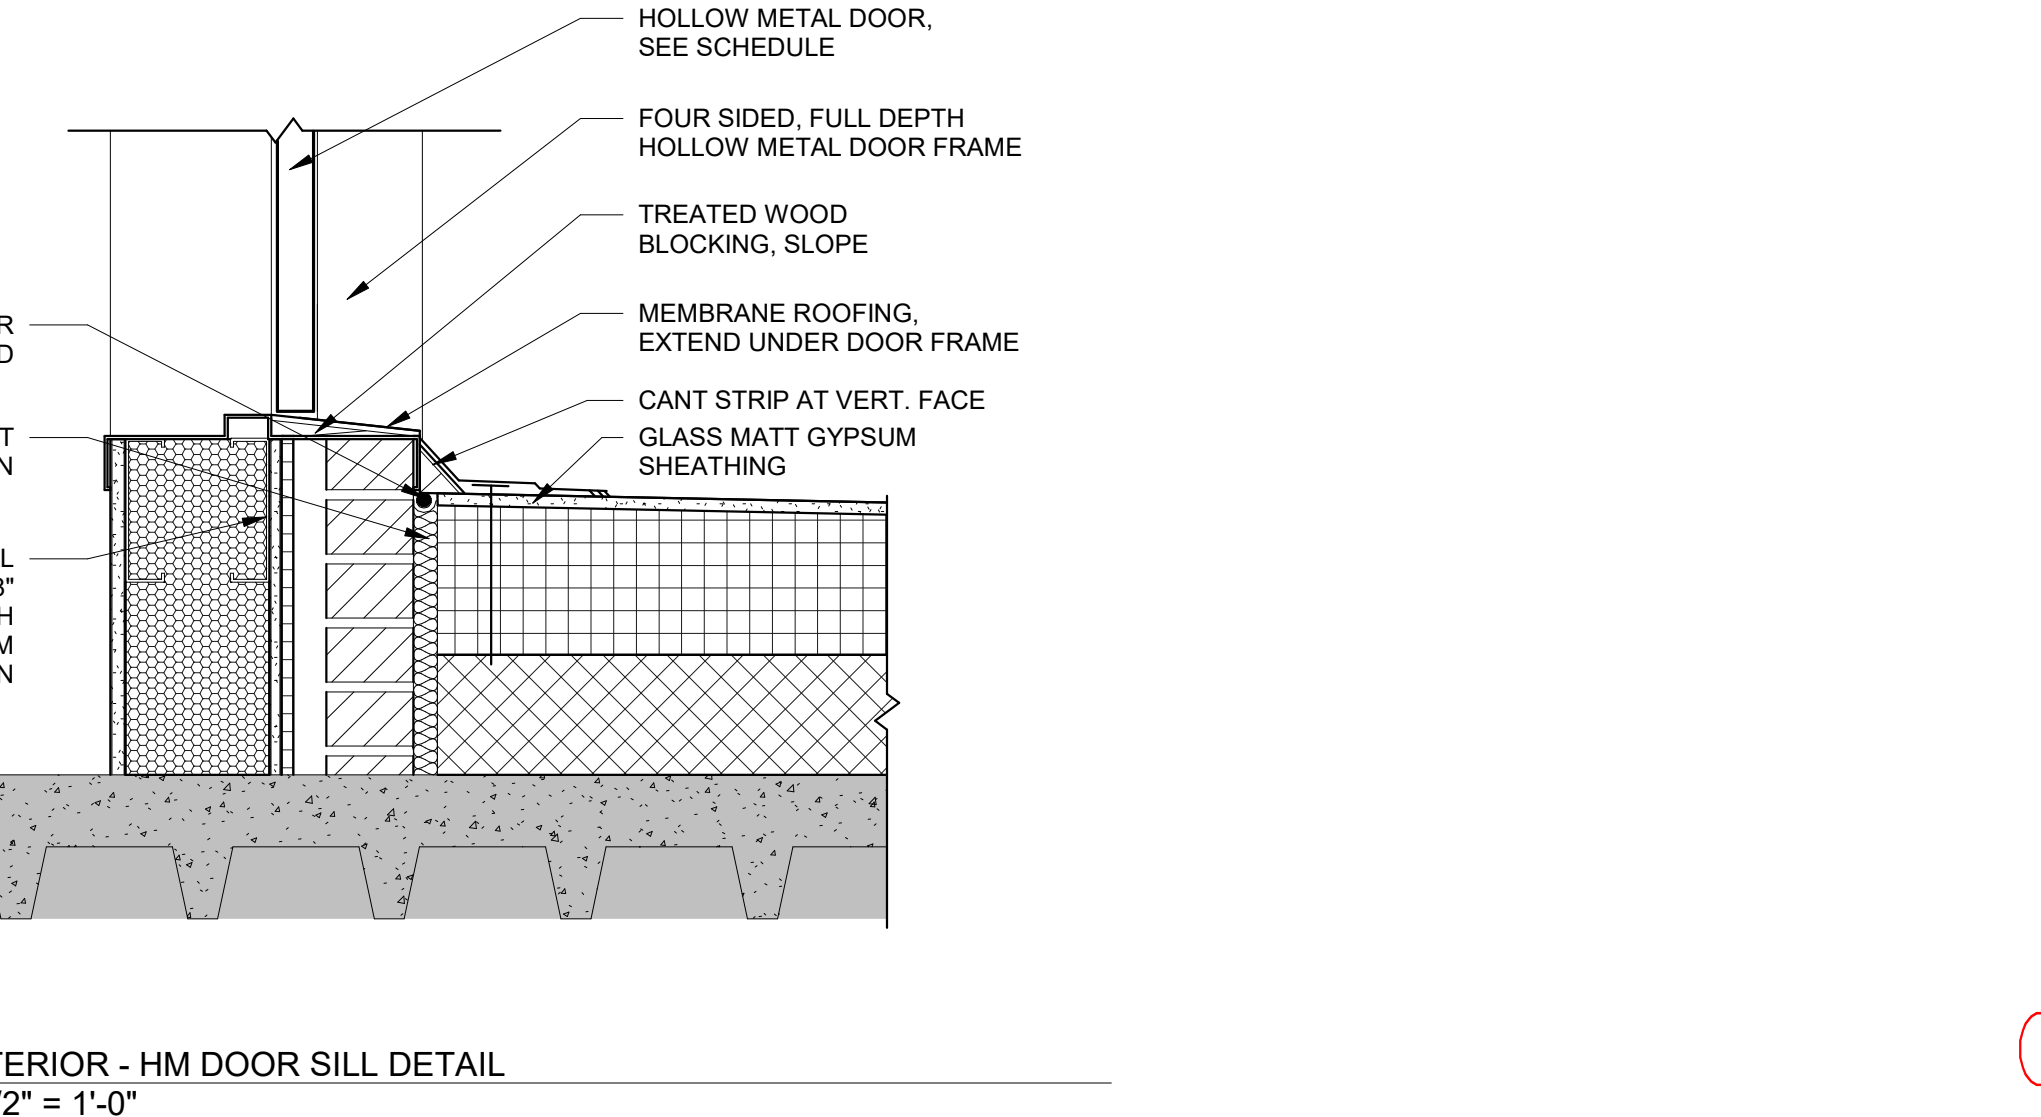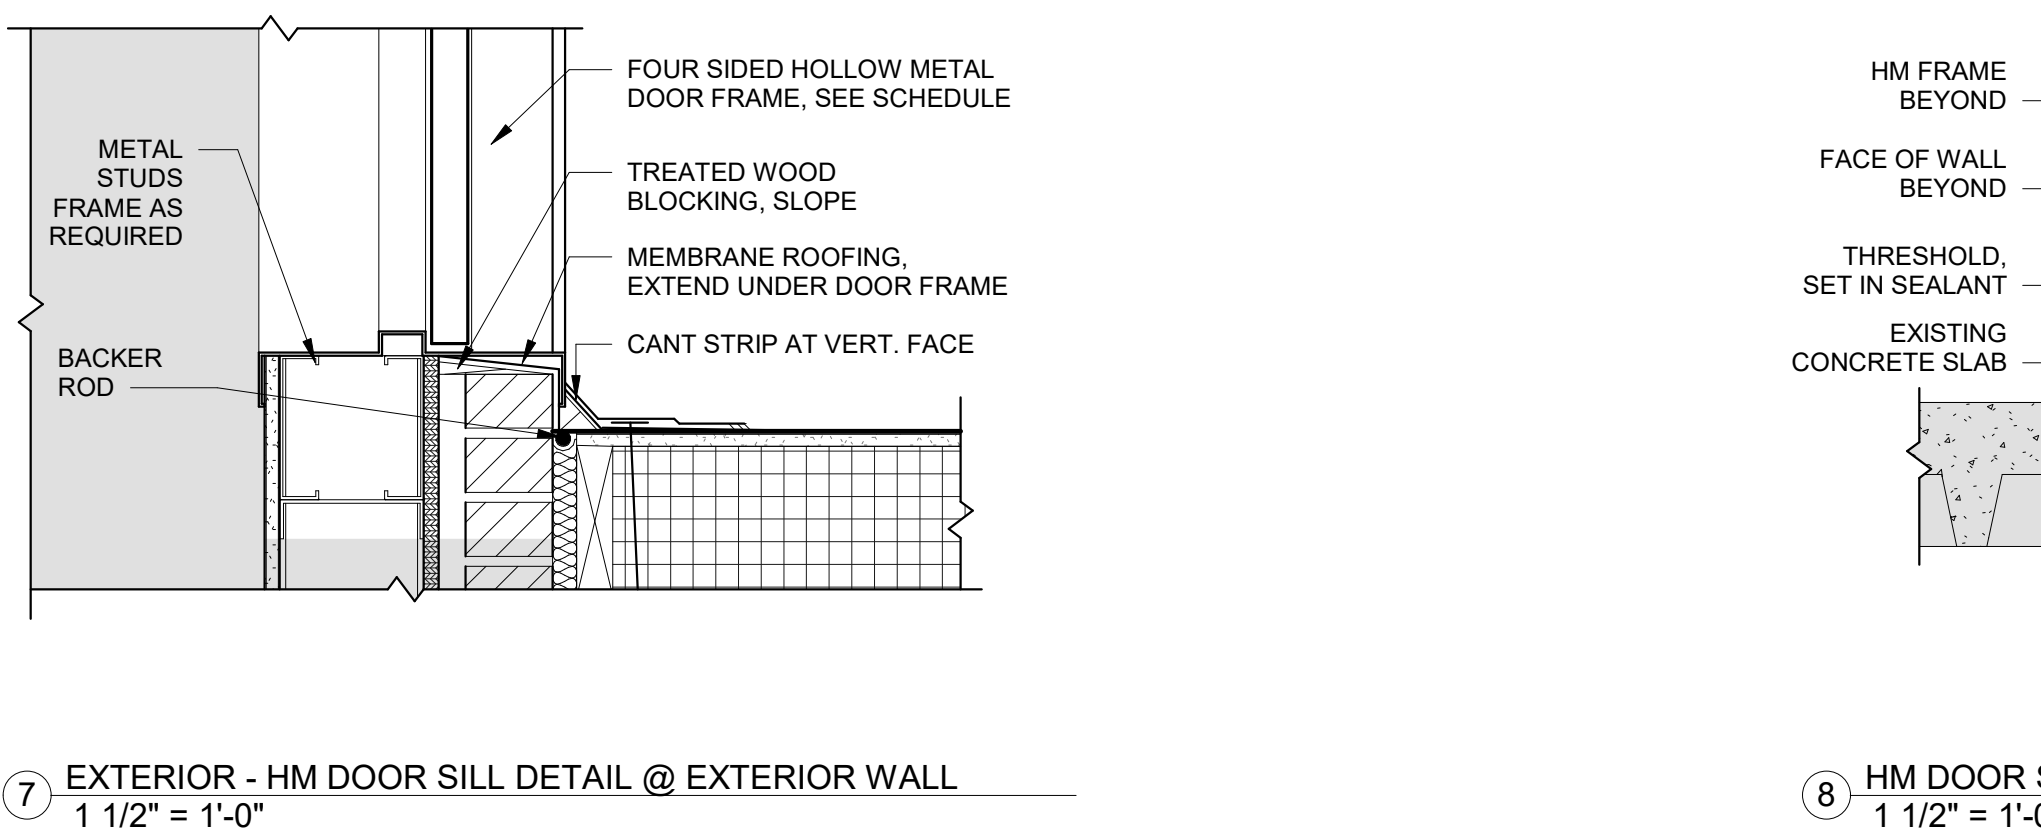
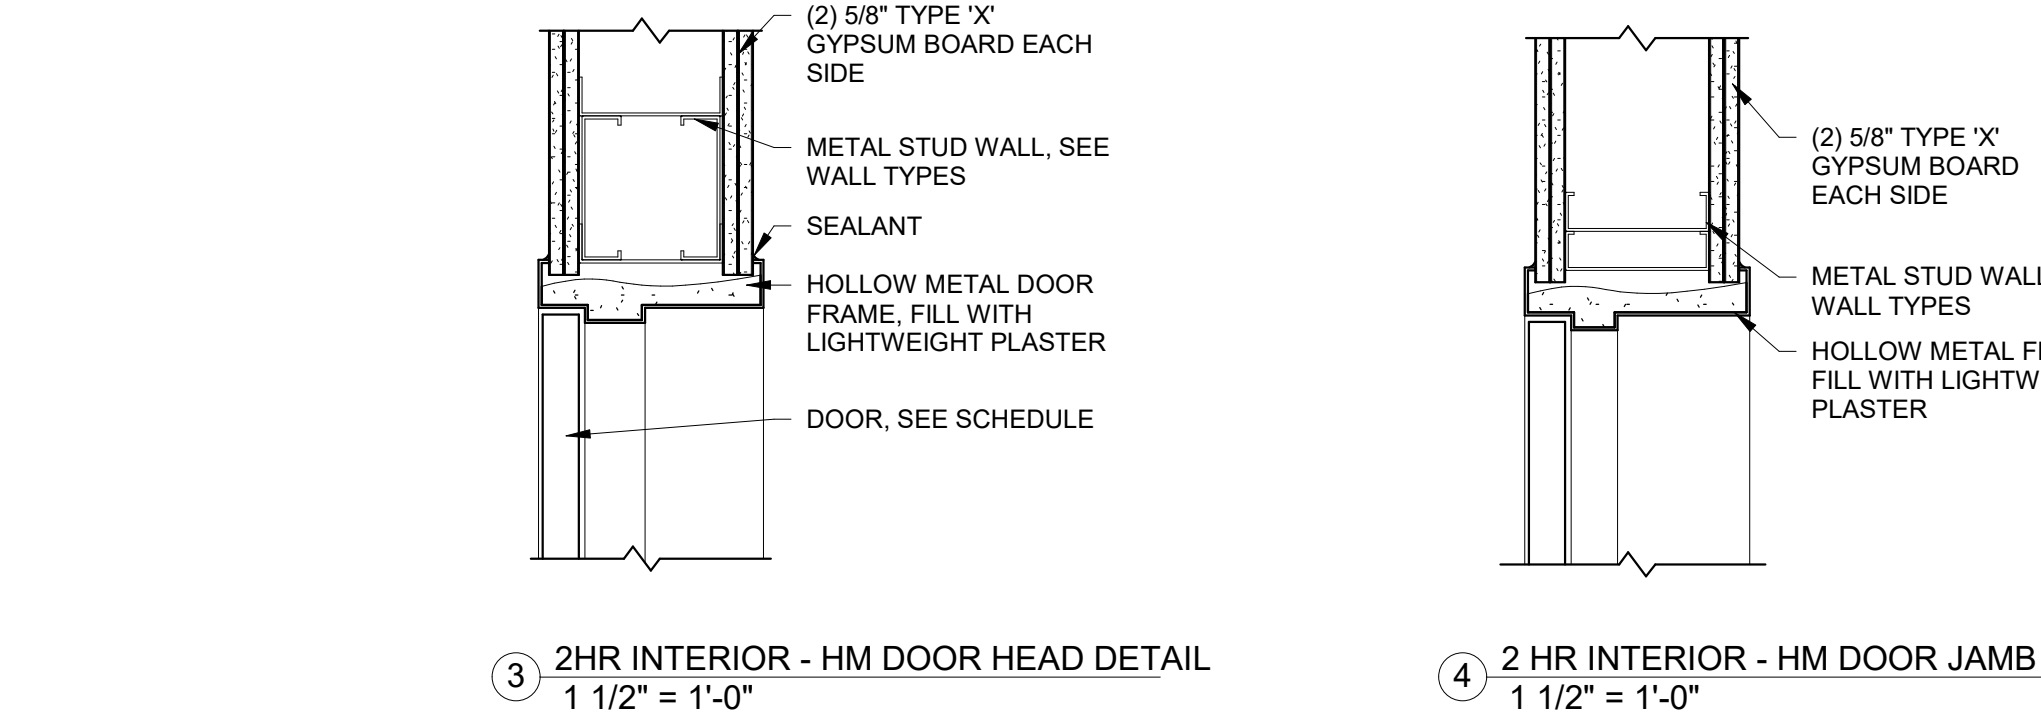
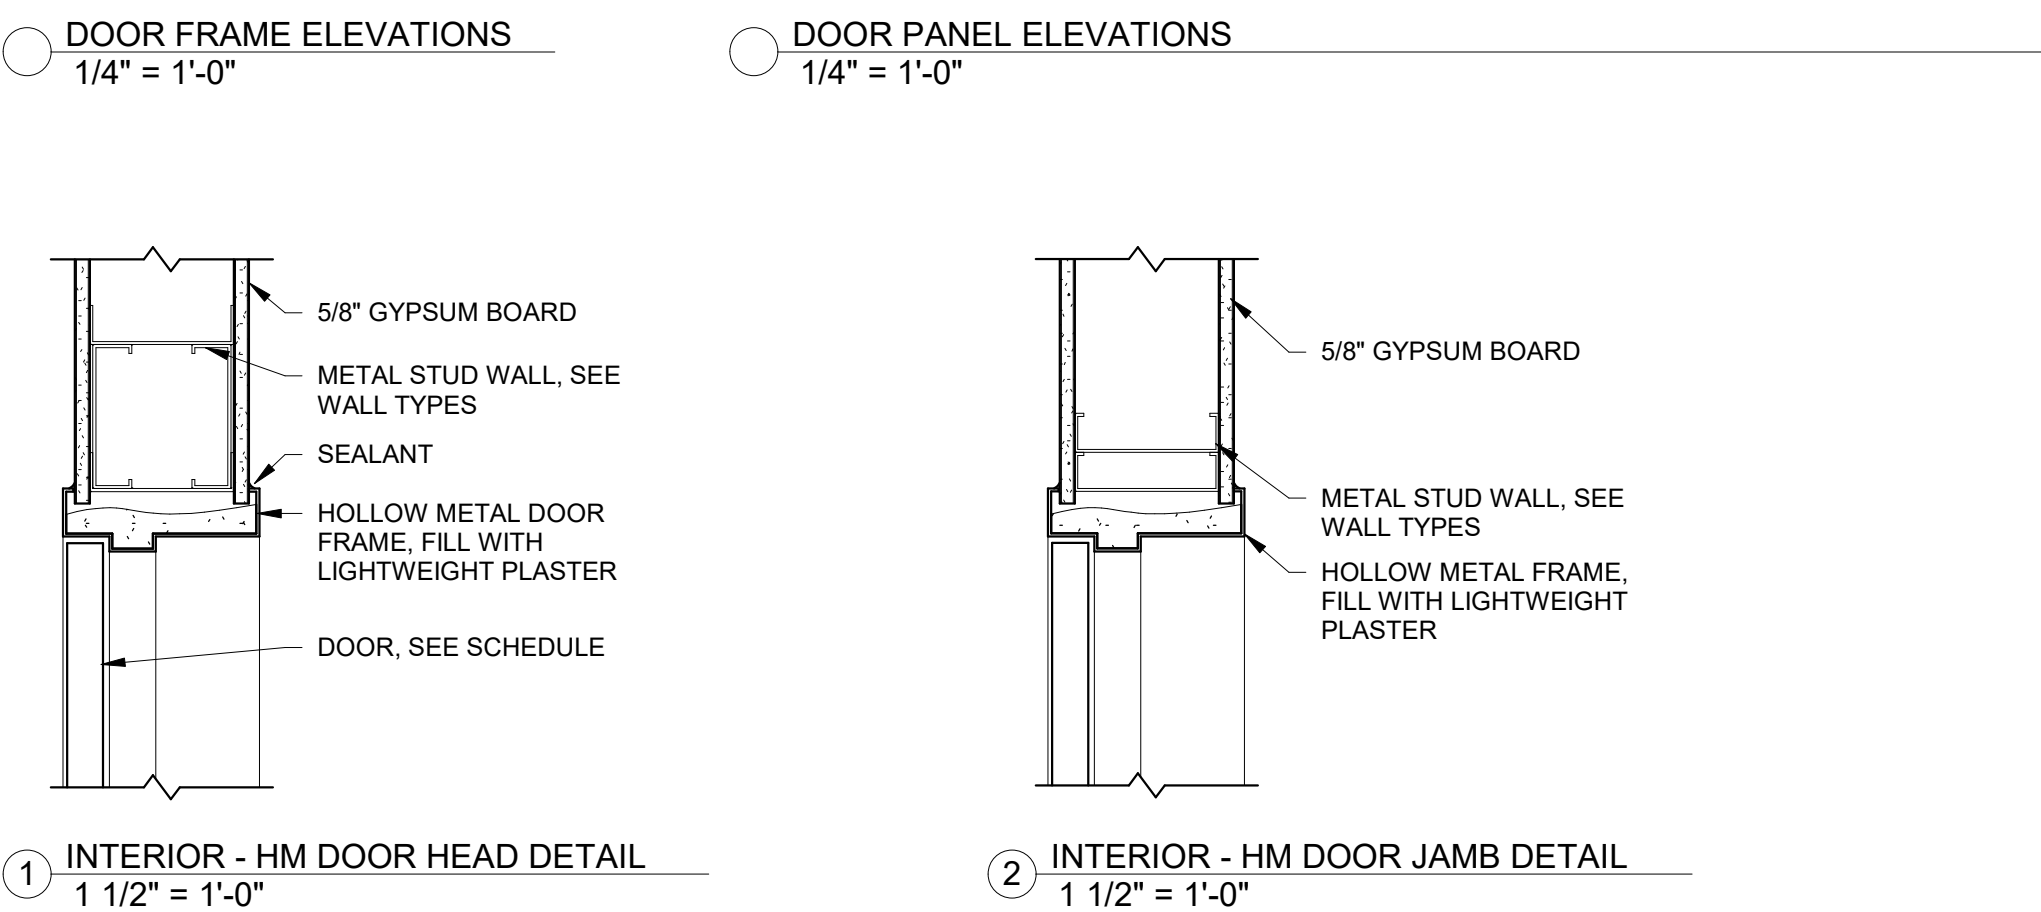


CONSTRUCTION DOCUMENTS







COMPLIANCE REVIEW COMPLETED Revisions:		2/23/2024 Date	
CONSULTANTS:			
 TERRASITE DESIGN 1635 DEADWOOD AVENUE RAPID CITY, SOUTH DAKOTA 57702 PH: (605) 791-1736		 ALBERTSON ENGINEERING, INC. 315 NORTH MAIN AVENUE, SUITE 200 SIOUX FALLS, SOUTH DAKOTA 57104 PH: (605) 274-0880	
 FARRIS ENGINEERING 12700 WEST DODGE ROAD OMAHA, NEBRASKA 68154 PH: (402) 330-5900			
ARCHITECT			
 FOURFRONT DESIGN, INC. 517 7TH STREET RAPID CITY, SOUTH DAKOTA 57701 PH: (605) 342-9470 FAX: (605) 342-2377 WWW.FOURFRONTDESIGN.COM			
Drawing Title DOOR SCHEDULE, ELEVATIONS AND DETAILS		Project Title Design/Construct Sterile Processing Service- Omaha VA Medical Center	
Approved: Project Director Omaha VA Medical Center		Location 4101 Woolworth Ave #4199 Omaha, Ne 68105	
Date 11/23/2020		Checked JL	
Drawn JGC		Building Number 25	
Project Number 16.2330.A08		Drawing Number A-600	
Dwg. 59 of 143		Office of Construction and Facilities Management Department of Veterans Affairs	

GENERAL NOTES:

1. SHEET SIZE FOR PROPER SCALE IS 30X42. CONTRACTOR SHALL NOT SCALE DRAWINGS BUT SHALL REQUEST THE DESIRED DIMENSIONS FROM THE ARCHITECT.
2. SEE SHEET G-002 FOR GENERAL NOTES.
3. APPLY 1-1/2" THICK FIREPROOFING AT ALL EXPOSED STEEL WITHIN INTERSTITIAL SPACE AND AT EXPOSED STEEL STRUCTURE ABOVE 3RD FLOOR CEILING, TYP.

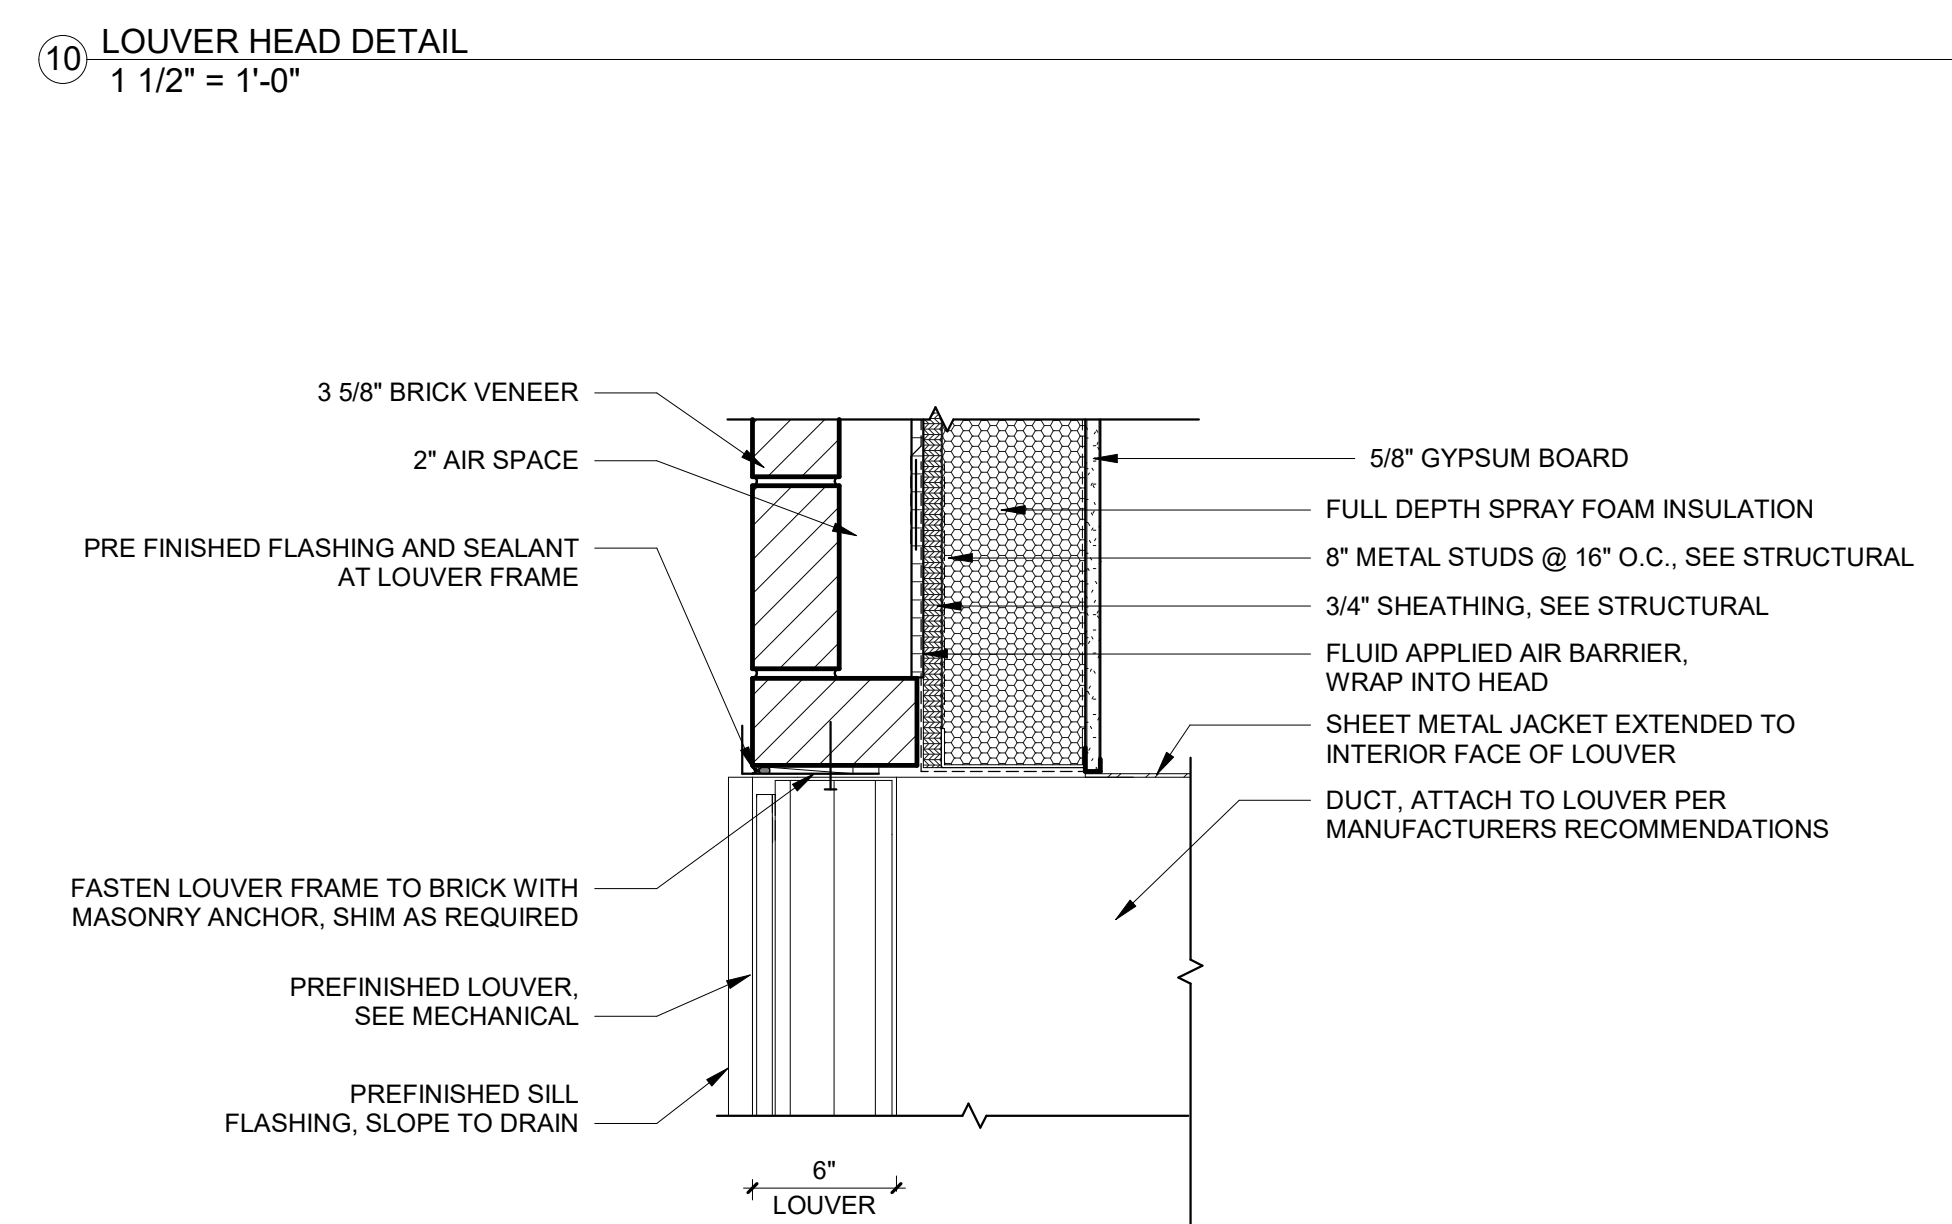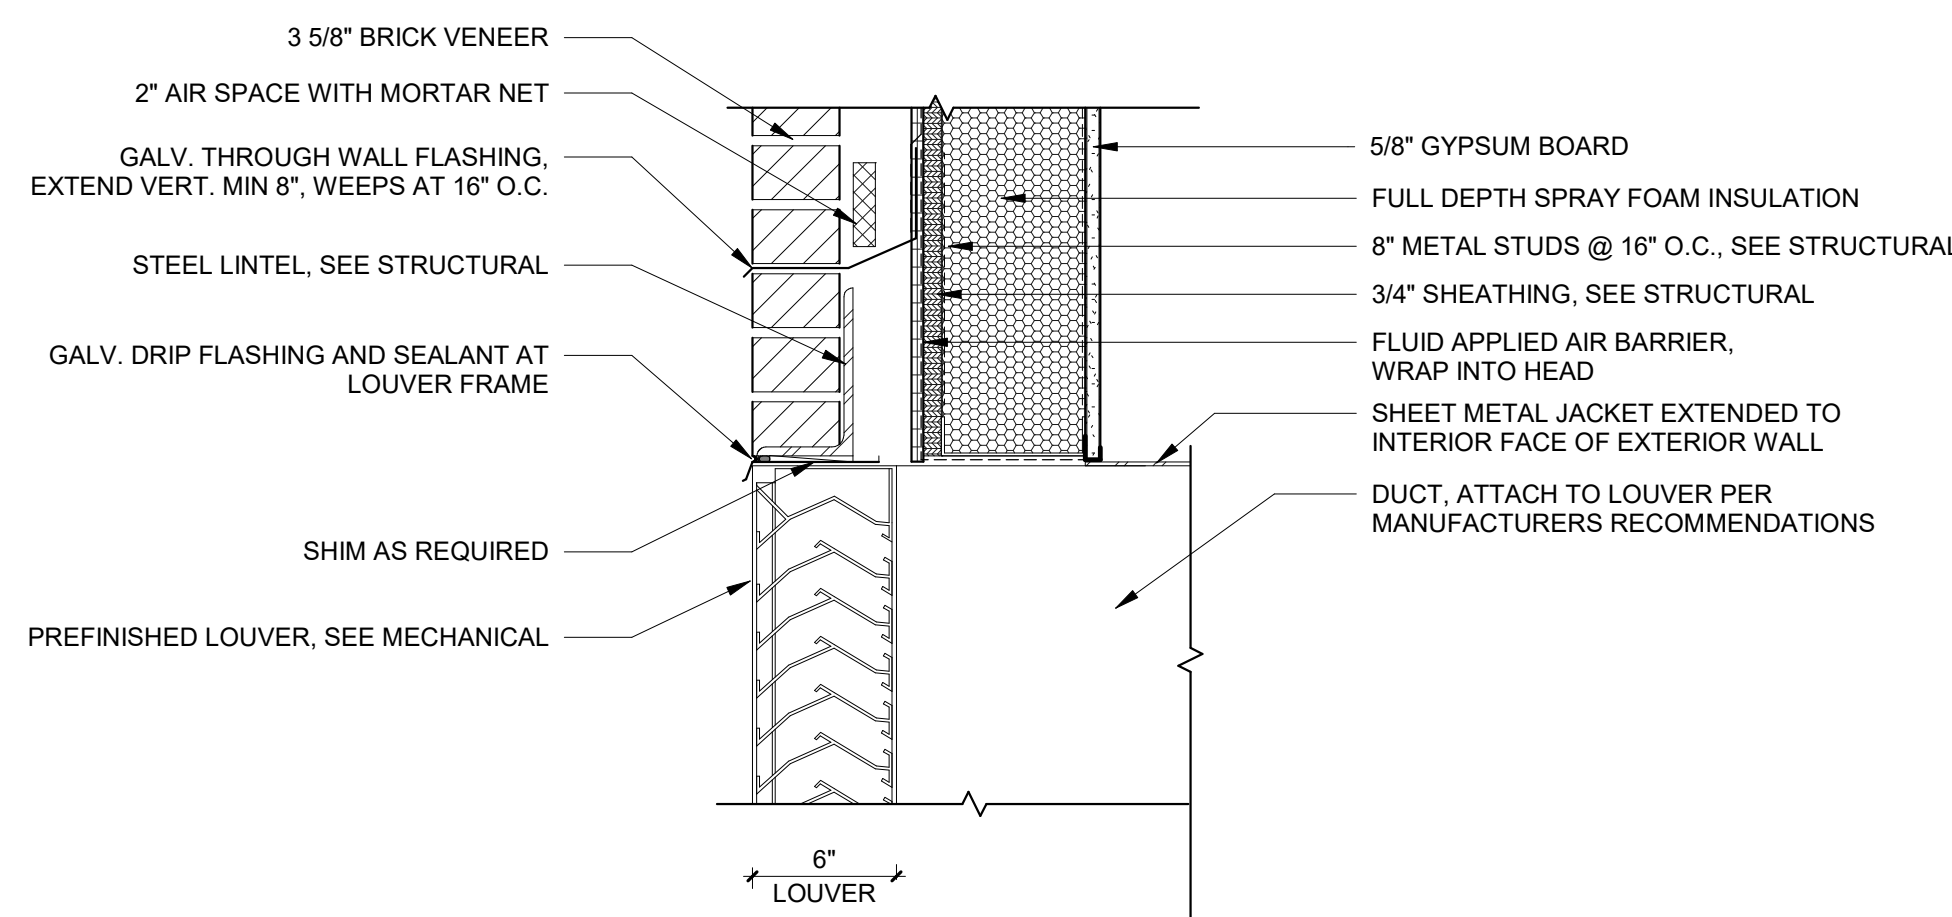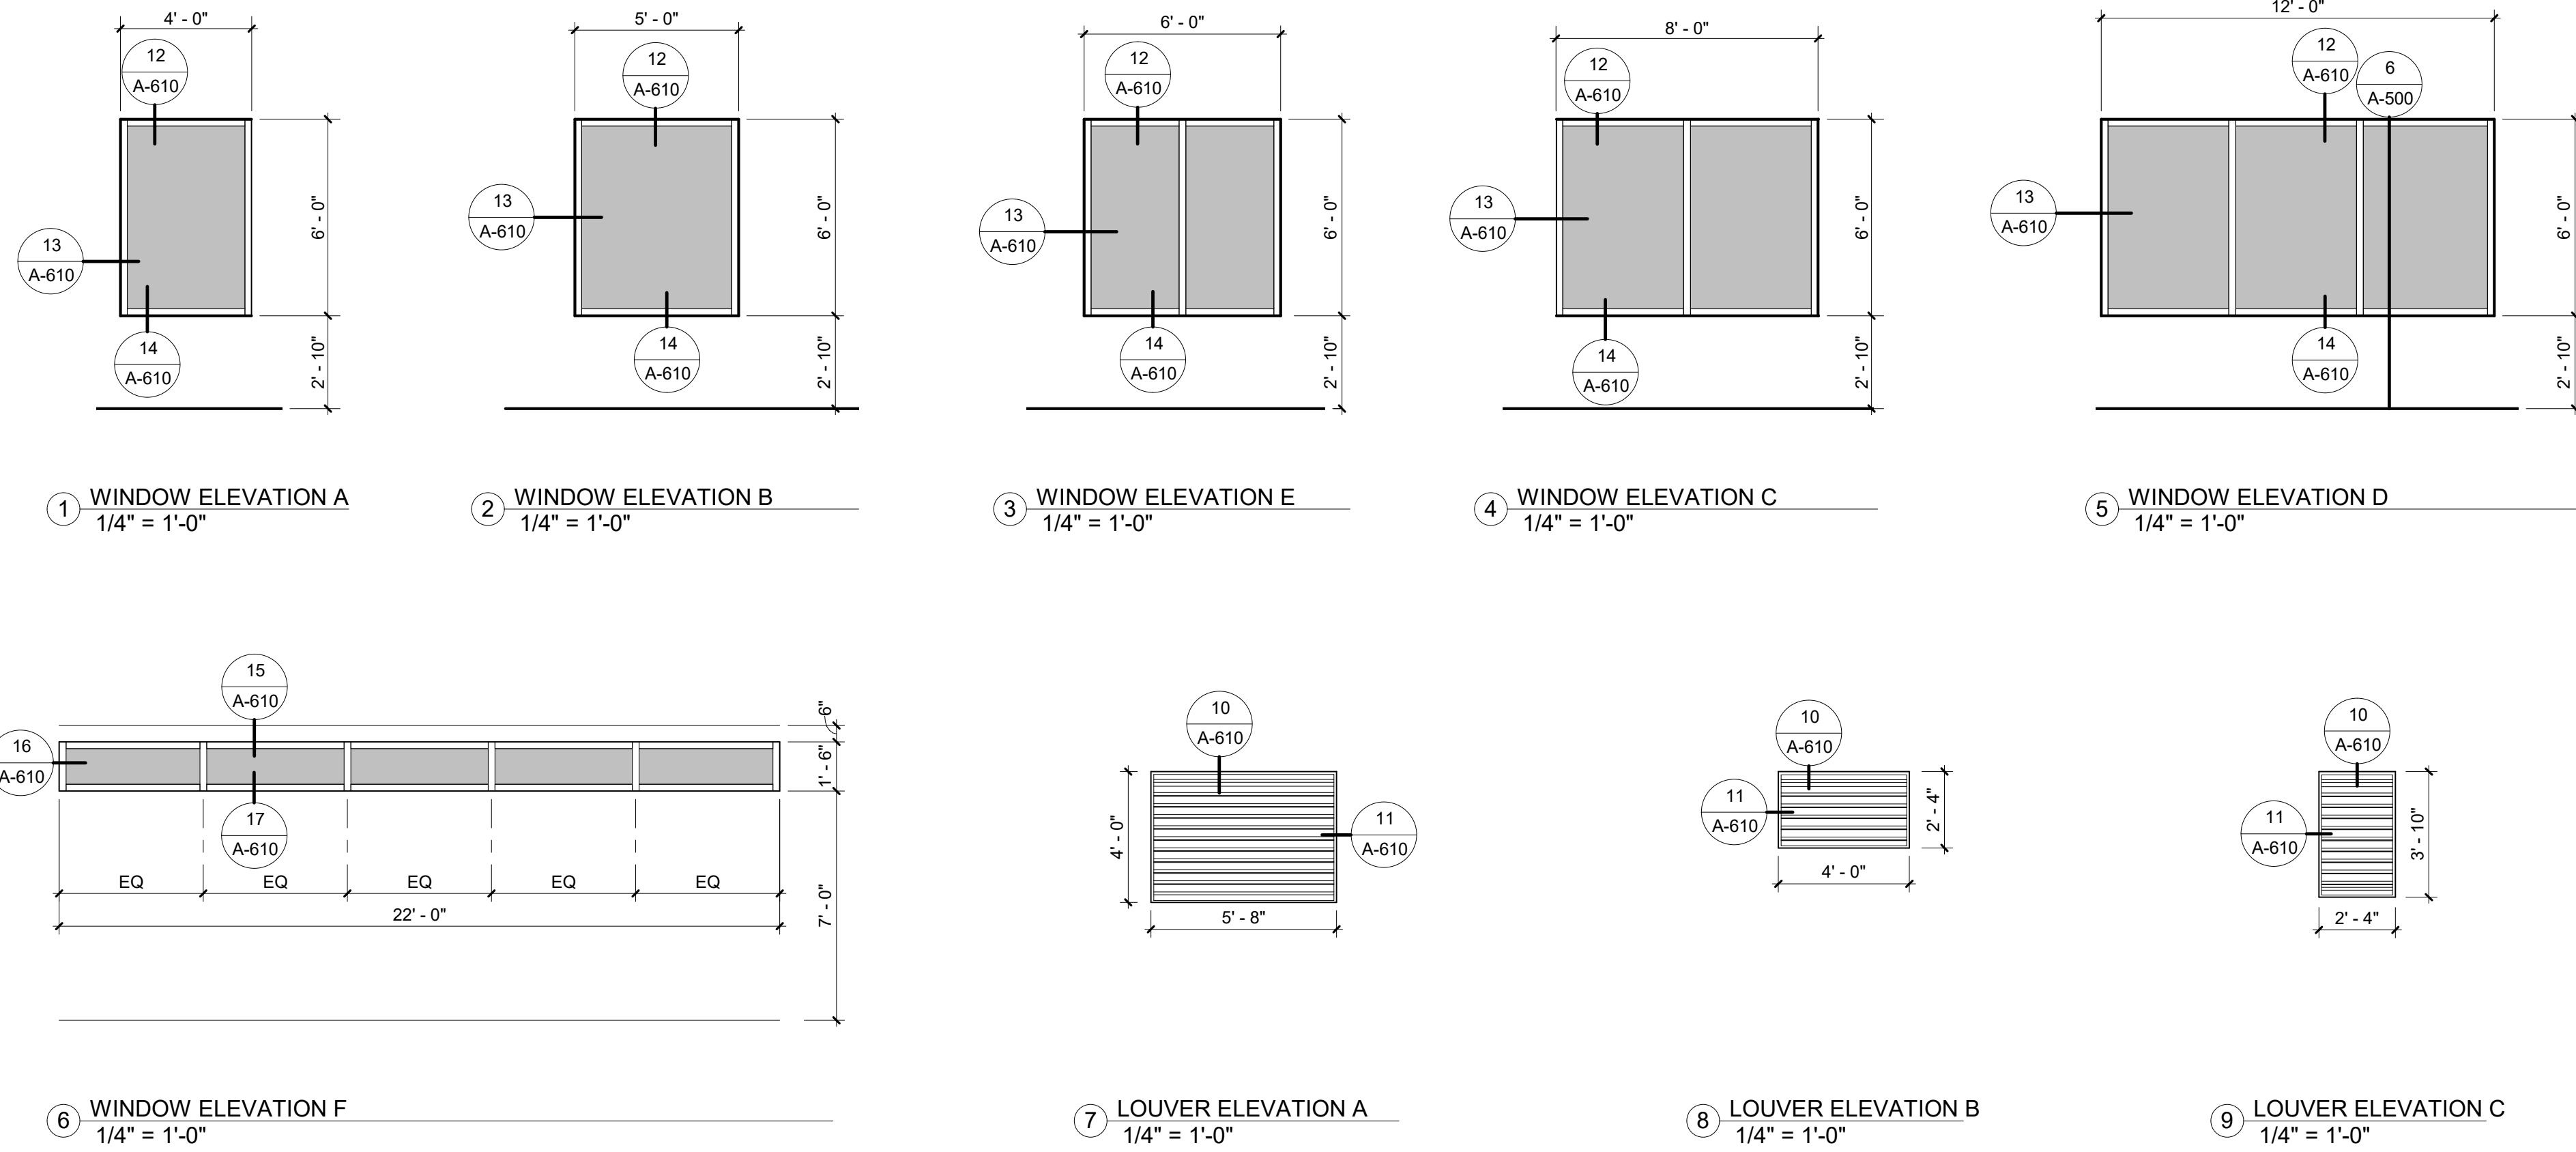

11 LOUVER JAMB DETAIL
1 1/2" = 1'-0"

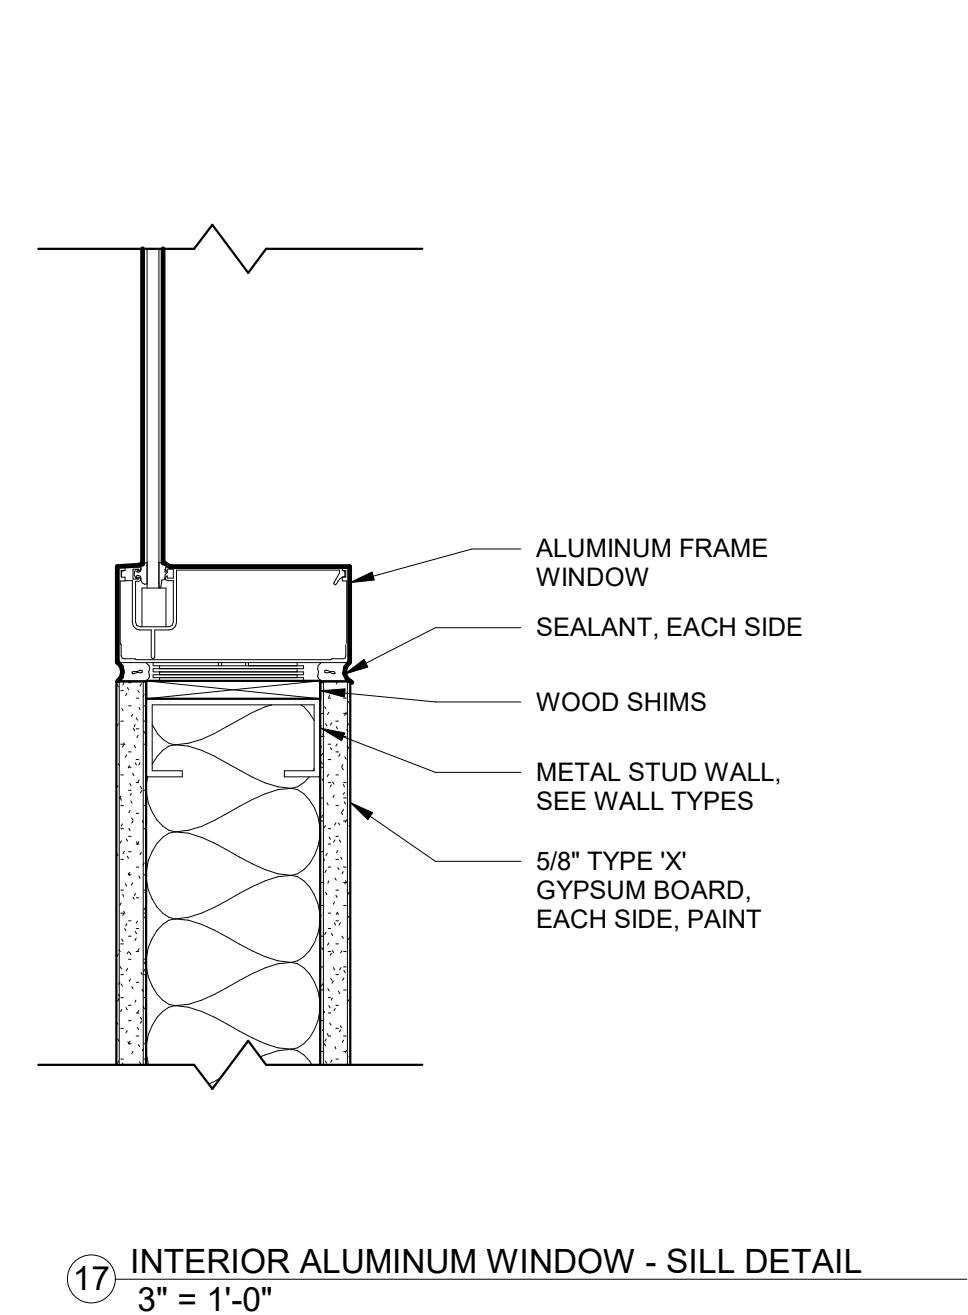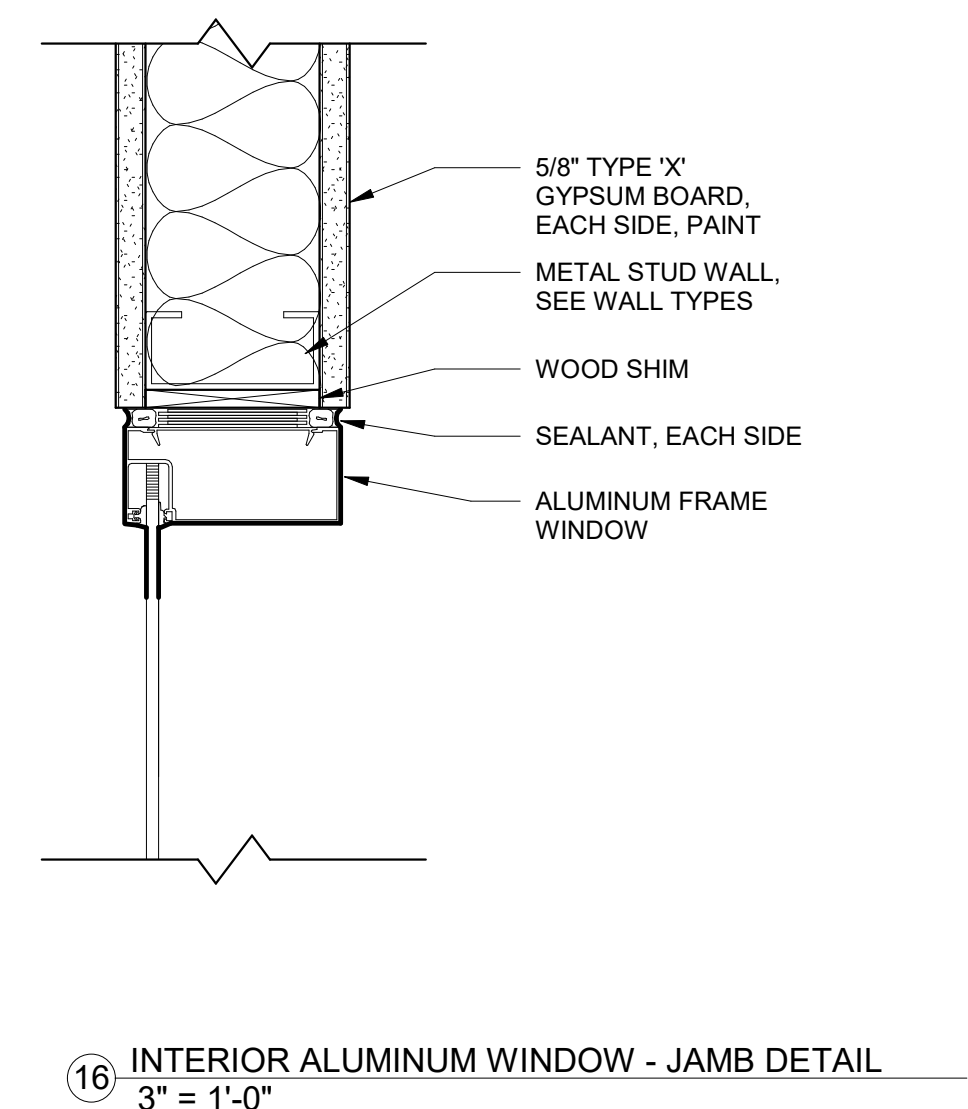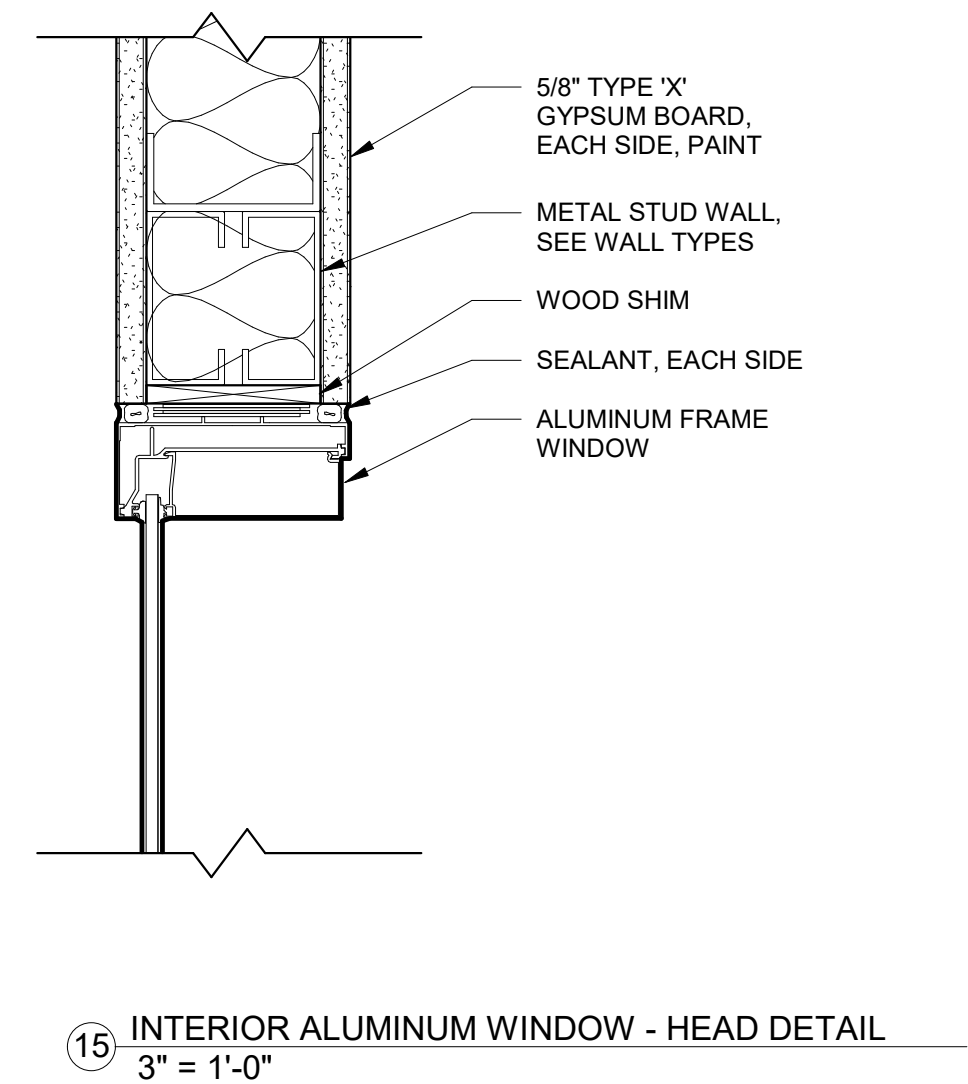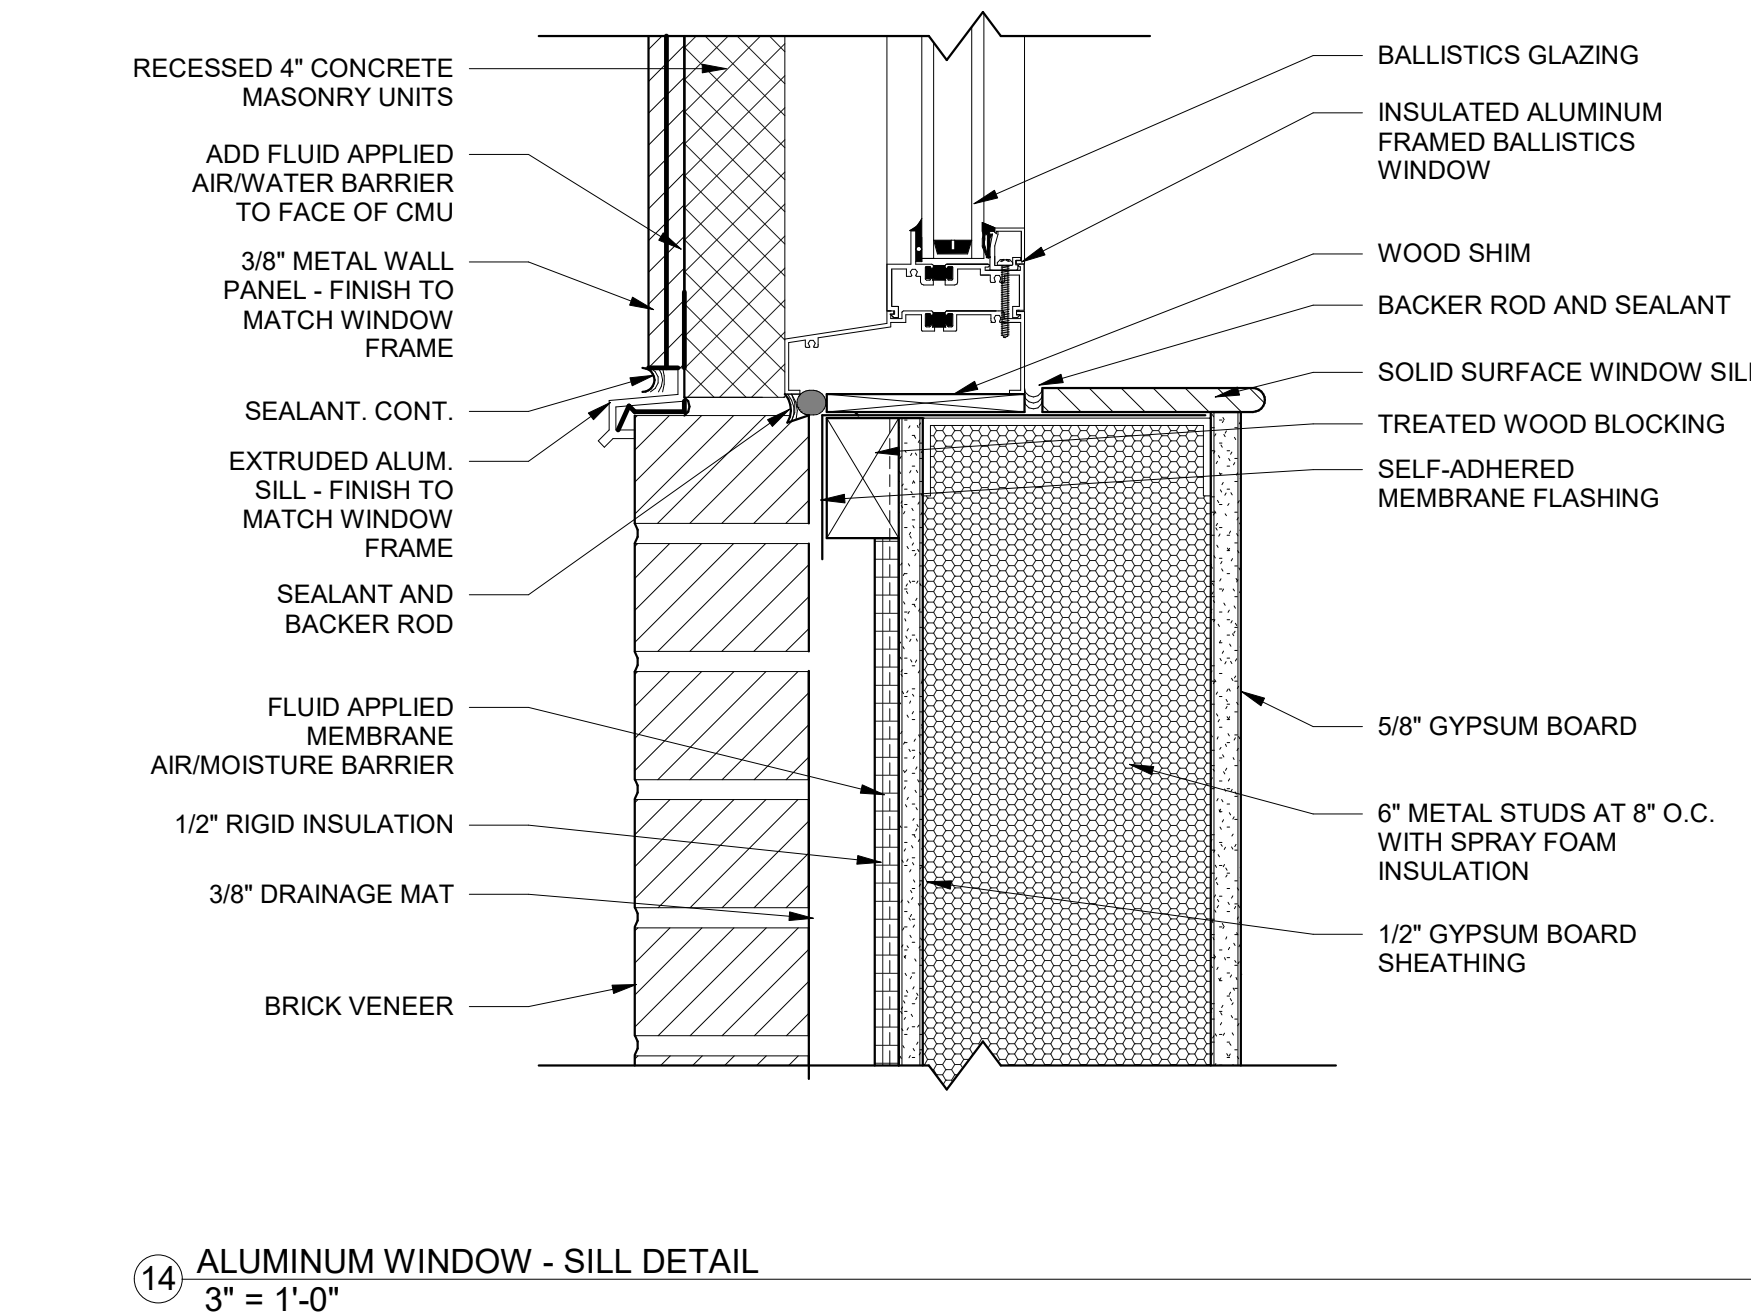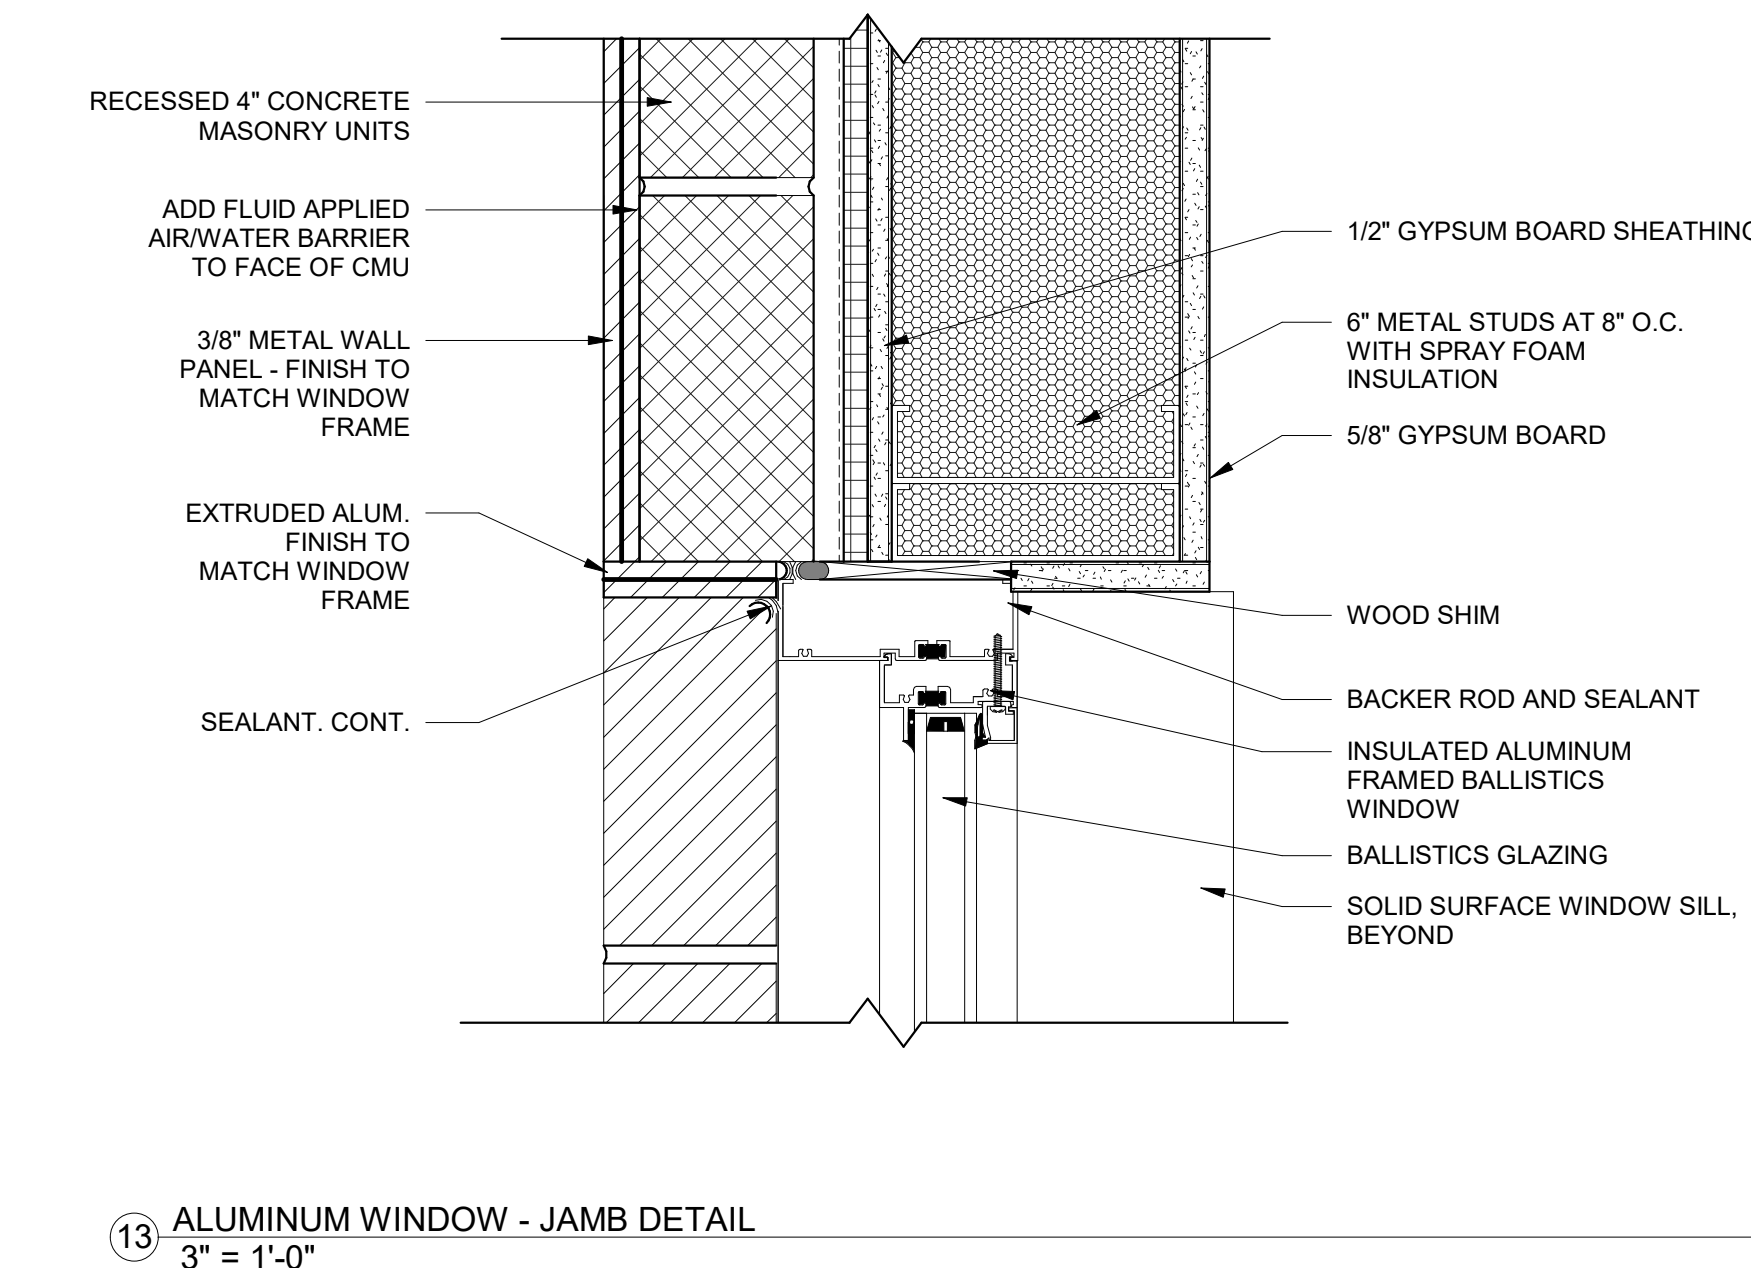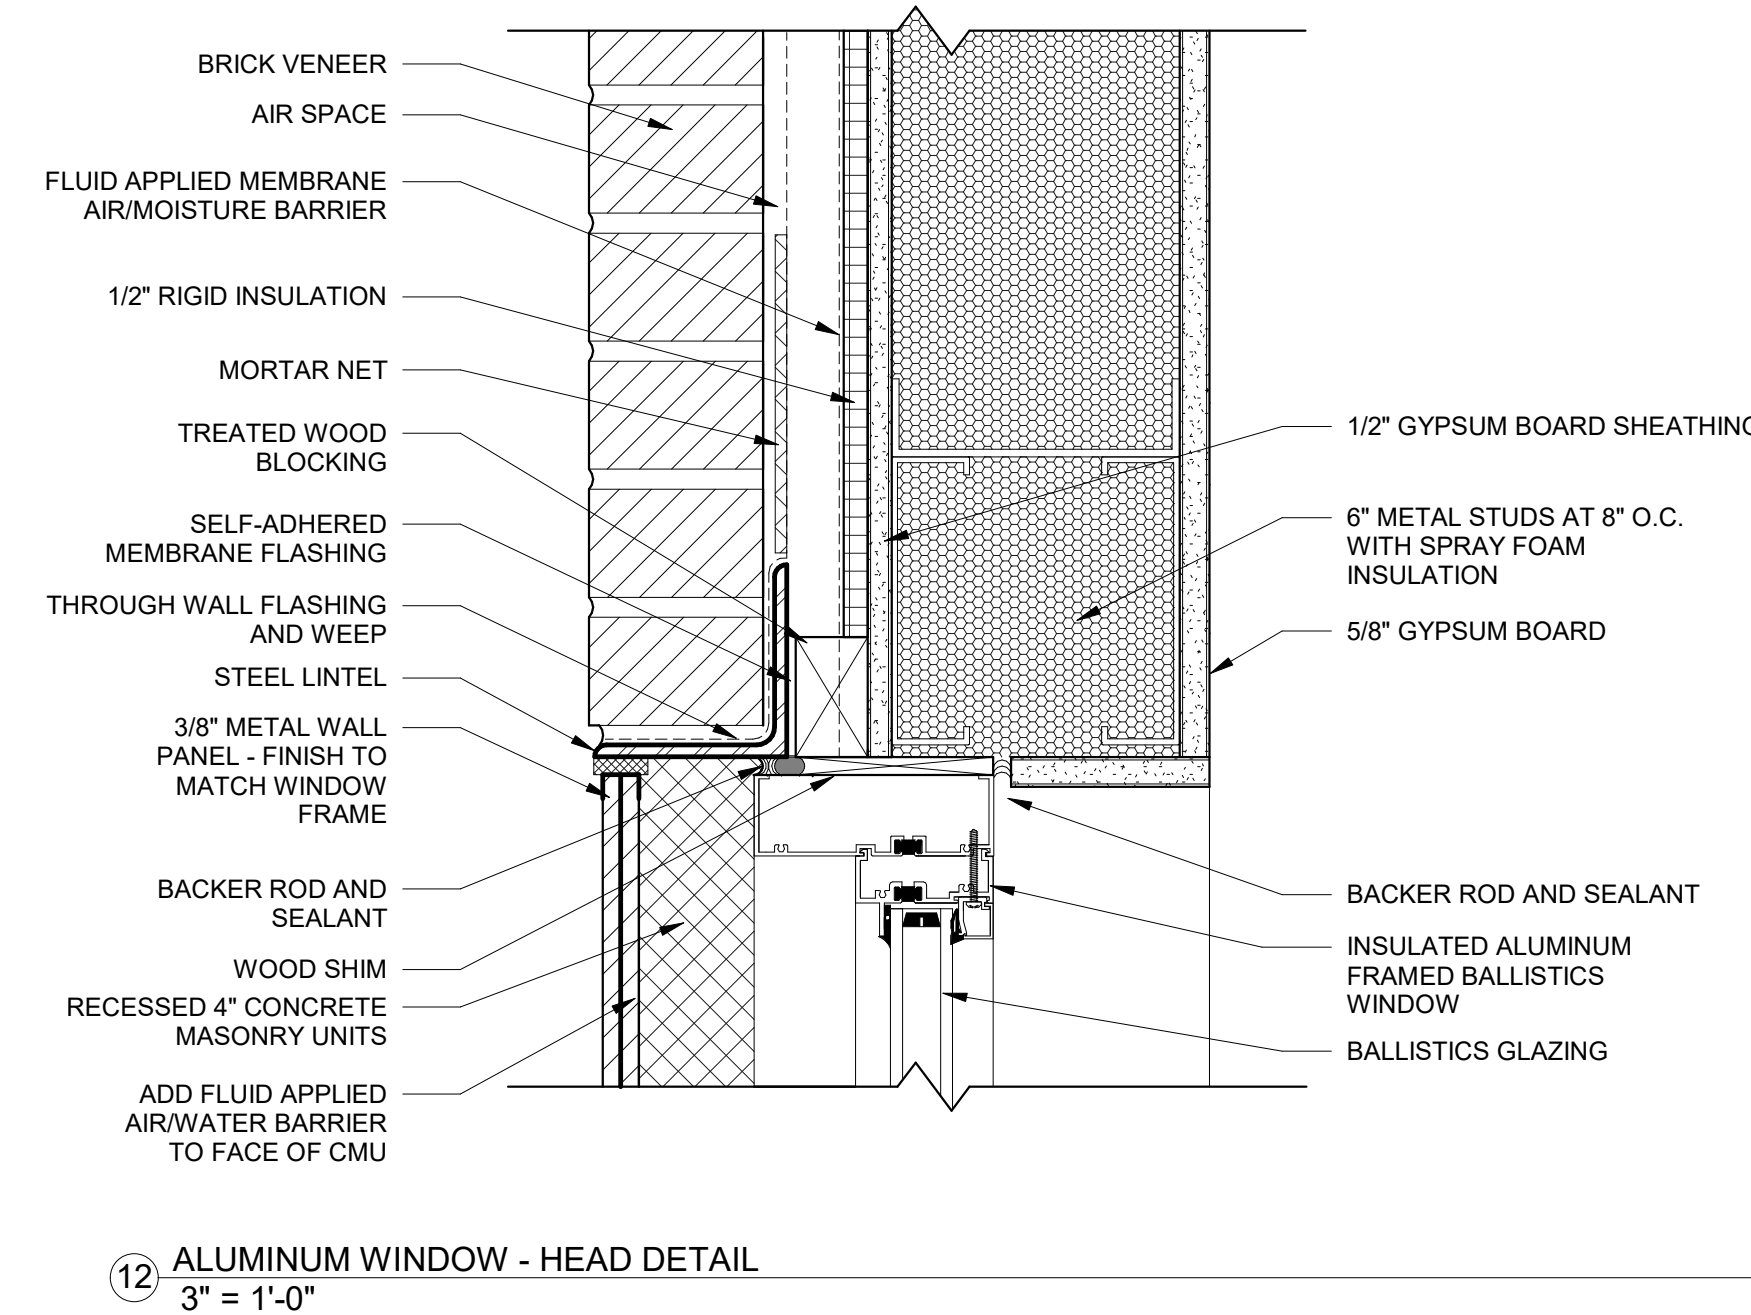

CONSTRUCTION DOCUMENTS

COMPLIANCY REVIEW COMPLETED Revisions:		2/23/2024 Date	
CONSULTANTS:			
 TERRASITE DESIGN 1635 DEADWOOD AVENUE RAPID CITY, SOUTH DAKOTA 57702 PH: (605) 274-0880		 ALBERTSON ENGINEERING, INC. 315 NORTH MAIN AVENUE, SUITE 200 SIOUX FALLS, SOUTH DAKOTA 57104 PH: (605) 274-0880	
 FARRIS ENGINEERING OMAHA (BRANCH) SENECA COUNCIL BLUFFS OMAHA, NEBRASKA 68154 PH: (402) 330-5900			
ARCHITECT			
 FOURFRONT DESIGN, INC. 517 7TH STREET RAPID CITY, SOUTH DAKOTA 57701 PH: (605) 342-9470 FAX: (605) 342-2377 WWW.FOURFRONTDESIGN.COM			
Drawing Title WINDOW ELEVATIONS AND DETAILS		Project Title Design/Construct Sterile Processing Service- Omaha VA Medical Center	
Approved: Project Director Omaha VA Medical Center		Location 4101 Woolworth Ave #4199 Omaha, Ne 68105	
Date 11/23/2020		Checked JL	Drawn JGC
Project Number 16.2330.A08		Building Number 25	
Drawing Number A-610		Dwg. 60 of 143	
Office of Construction and Facilities Management Department of Veterans Affairs			