

DRAWING INDEX

VOLUME 1

GENERAL

SHEET NO.	SHEET NAME
00-GI-000.1	COVER SHEET VOLUME 1
00-GI-001	INDEX OF DRAWINGS
00-GI-002	PROJECT CODE SUMMARY
00-GI-003	GENERAL NOTES
00-GI-004	PROJECT SITE PLAN
00-GI-005	PROJECT ASSEMBLY TYPES
00-GI-006	DOOR SCHEDULE AND DETAILS
00-GI-007	PARTITION DETAILS
00-GI-008	FIRE PROTECTION

CIVIL

SHEET NO.	SHEET NAME
C00001	GENERAL NOTES
RC0001	EXISTING CONDITIONS PLAN
CS0001	SECONDARY FIBER OPTICS SITE PLAN
CU0100	SECONDARY FIBER OPTICS PLAN AND PROFILE
CU0101	SECONDARY FIBER OPTICS PLAN AND PROFILE
CG0100	BUILDING 1 TELECOM GRADING PLAN
CG0101	BUILDING 1 TELECOM EROSION CONTROL PLAN
CG0200	BUILDING 66 TELECOM GRADING PLAN
CG0300	BUILDING 11 TELECOM GRADING PLAN
CJ0001	DETAILS
CJ0002	DETAILS
CJ0003	DETAILS

STRUCTURAL

SHEET NO.	SHEET NAME
00-SN-001	STRUCTURAL NOTES
00-SN-002	STRUCTURAL NOTES
01-SF-100	11 - PLANS
01-SD-100	DETAILS
01-SD-101	DETAILS
01-SD-102	DETAILS
11-SF-100	11 - PLANS
11-SD-100	DETAILS
66-SF-100	66 - PLANS
66-SD-100	DETAILS

ARCHITECTURAL - DEMOLITION

SHEET NO. SHEET NAME

01-AD-201	01-BASEMENT & FIRST FLOOR DEMOLITION PLANS
01-AD-202	01-SECOND AND THIRD FLOOR DEMOLITION PLANS
02-AD-201	02-DEMOLITION PLANS
03-AD-201	03-DEMOLITION FLOOR PLANS
04-AD-201	BUILDING 4 DEMOLITION FLOOR PLANS
05-AD-201	05-DEMOLITION FLOOR PLANS
06-AD-201	06-DEMOLITION PLANS
07-AD-201	07-DEMOLITION FLOOR PLANS
08-AD-201	08-DEMOLITION FLOOR PLANS
10-AD-201	DEMOLITION FLOOR PLANS
11-AD-201	11-DEMOLITION PLANS
12-AD-201A	12-DEMOLITION BASEMENT FLOOR ENLARGED PLAN SECTOR A
12-AD-201B	12-DEMOLITION BASEMENT FLOOR ENLARGED PLAN SECTOR D
12-AD-202A	12-DEMOLITION GROUND FLOOR ENLARGED PLAN SECTORS B, C, AND D
12-AD-202BCD	12-DEMOLITION GROUND FLOOR ENLARGED PLAN SECTORS B, C, AND D
12-AD-203	12-DEMOLITION FIRST FLOOR ENLARGED PLAN SECTOR A
12-AD-204	12-DEMOLITION SECOND FLOOR ENLARGED PLAN SECTOR A
12-AD-205D	12-DEMOLITION THIRD FLOOR ENLARGED PLAN SECTORS B, C, AND D
12-AD-206	12-DEMOLITION FOURTH FLOOR ENLARGED PLAN SECTOR D
14-AD-201	14- DEMOLITION FLOOR PLANS
53-AD-201	53-DEMOLITION FLOOR PLANS
65-AD-201	65-DEMOLITION PLAN
66-AD-201	66-FIRST FLOOR DEMOLITION PLAN

ARCHITECTURAL - NEW CONSTRUCTION

SHEET NO. SHEET NAME

00-DOM-AE-101	00-DOM-FLOOR PLANS
01-AE-101	01-BASEMENT & FIRST FLOOR LIFE SAFETY PLAN
01-AE-102	01-SECOND & THIRD FLOOR LIFE SAFETY PLANS
01-AE-200	01-BASEMENT, FIRST, AND SECOND FLOOR PLANS
01-AE-201	01-FIRST FLOOR PLAN
01-AE-202	01-SECOND FLOOR PLAN
01-AE-203	01-THIRD FLOOR PLAN
01-AE-204	01-ROOF PLAN AND ROOF DETAILS
01-AE-205	01-SLAB EDGE PLANS
01-AE-401	01-OVERALL ELEVATIONS
01-AE-402	01-ENLARGED ELEVATIONS
01-AE-501	01-WALL SECTIONS
01-AE-502	01-WALL SECTIONS
01-AE-503	01-SECTION DETAILS
01-AE-504	01-SECTION DETAILS
01-AE-505	01-PLAN DETAILS
01-AE-601	01-TR ELEVATIONS
01-AE-602	01-TR ELEVATIONS
01-AE-801	01-STAIR SECTIONS
01-AE-802	01-STAIR DETAILS
02-AE-200	02-FLOOR PLANS
02-AE-601	02-ENLARGED TR PLANS & INTERIOR ELEVATIONS
03-AE-201	03-BASEMENT, FIRST, AND SECOND FLOOR PLANS
03-AE-202	03-TR PLANS AND ELEVATIONS
04-AE-200	04-BASEMENT, FIRST, & SECOND FLOOR PLANS
05-AE-201	05-BASEMENT, FIRST, & SECOND FLOOR PLANS
05-AE-601	05-ENLARGED TR & ELEVATIONS
06-AE-200	06-BASEMENT, FIRST, & SECOND FLOOR PLANS
06-AE-601	ENLARGED TR PLANS & ELEVATIONS
07-AE-200	07-BASEMENT, FIRST, & SECOND FLOOR PLANS
07-AE-201	07- ENLARGED TR PLANS & ELEVATIONS
08-AE-200	08-BASEMENT, FIRST, AND SECOND FLOOR PLANS
08-AE-201	08-ENLARGED TR PLANS AND INTERIOR ELEVATIONS
09-AE-201	09-FLOOR & ROOF PLANS
10-AE-200	10-FLOOR PLANS
11-AE-200	11-GROUND, FIRST, AND SECOND FLOOR PLANS
11-AE-301	11-ENLARGED PLANS & INT ELEVATIONS
11-AE-501	11-EXTERIOR SECTIONS AND ELEVATIONS

ARCHITECTURAL - NEW CONSTRUCTION (CONTINUED)

SHEET NO.	SHEET NAME
11-AE-502	11-PLAN AND SECTION DETAILS
12-AE-101	12-BASEMENT & GROUND FLOOR OVERALL LIFE SAFETY PLAN
12-AE-102	12-FIRST & SECOND FLOOR OVERALL LIFE SAFETY PLAN
12-AE-103	12-THIRD AND FOURTH FLOOR OVERALL LIFE SAFETY PLANS
12-AE-201	12-BASEMENT FLOOR PLAN
12-AE-201A	12-BASEMENT FLOOR ENLARGED PLANS SECTOR A
12-AE-201CD	12-BASEMENT FLOOR ENLARGED PLANS SECTORS C AND D
12-AE-202	12-GROUND FLOOR PLAN
12-AE-202A	12-GROUND FLOOR ENLARGED PLAN SECTOR A
12-AE-202BCD	12-GROUND FLOOR ENLARGED PLANS SECTORS B, C, AND D
12-AE-203	12-FIRST FLOOR PLAN
12-AE-203A	12-FIRST FLOOR ENLARGED PLAN - SECTOR A
12-AE-203BCD	12-FIRST FLOOR ENLARGED PLANS - SECTORS B, C, AND D
12-AE-204	12-SECOND FLOOR PLAN
12-AE-204A	12-SECOND FLOOR ENLARGED PLANS SECTOR A
12-AE-204BCD	12-SECOND FLOOR ENLARGED PLANS - SECTORS B, C, AND D
12-AE-205	12-THIRD AND FOURTH FLOOR PLANS
12-AE-205BCD	12-THIRD FLOOR ENLARGED PLANS SECTORS B, C, AND D
12-AE-206	12-FOURTH FLOOR ENLARGED PLAN
12-AE-301	12-ENLARGED PBX FLOOR PLAN & RCP
12-AE-302	12-ENLARGED TR PLANS
12-AE-601	12-ENLARGED TR ELEVATIONS
12-AE-602	12-ENLARGED TR ELEVATIONS
12-AE-603	12-ENLARGED TR ELEVATIONS
14-AE-201	14- FLOOR PLANS
18-AE-201	18-FLOOR PLANS
43-AE-201	43 - FIRST FLOOR PLANS
53-AE-201	53-FLOOR PLANS
53-AE-301	ENLARGED FLOOR PLANS & ELEVATIONS
65-AE-201	65-FLOOR PLAN
65-AE-301	65-FLOOR PLANS
66-AE-201	66-FLOOR PLAN
66-AE-202	ENLARGED FLOOR PLANS
66-AE-401	66-ELEVATIONS AND SECTION
66-AE-501	66-PLAN AND SECTION DETAILS
66-AE-601	TR ELEVATIONS

END OF VOLUME 1

VOLUME 2

GENERAL

SHEET NO.	SHEET NAME
00-GI-000.2	COVER SHEET VOLUME 2
00-GI-001	INDEX OF DRAWINGS

HAZARD ABATEMENT

SHEET NO. SHEET NAME

00-HA-000.1	GENERAL NOTES & QUANTITIES FOR HAZARDS ABATEMENT PLANS
00-HA-001	00-BASEMENT & FIRST FLOOR HAZARDS ABATEMENT PLANS
01-HA-001	01-BASEMENT HAZARDS ABATEMENT PLANS
01-HA-011	01-FIRST FLOOR HAZARDS ABATEMENT PLANS
001-HA-021	01-SECOND FLOOR HAZARDS ABATEMENT PLANS
001-HA-031	01-THIRD FLOOR HAZARDS ABATEMENT PLANS
002-HA-001	02-BASEMENT & SUB-BASEMENT HAZARDS ABATEMENT PLANS
002-HA-011	02-FIRST & SECOND FLOOR HAZARDS ABATEMENT PLANS
003-HA-001	03-BUILDING 03 HAZARDS ABATEMENT PLANS
004-HA-001	04-BUILDING 04 HAZARDS ABATEMENT PLANS
005-HA-001	05-BUILDING 05 HAZARDS ABATEMENT PLANS
006-HA-001	06-BUILDING 06 HAZARDS ABATEMENT PLANS
007-HA-001	07-BUILDING 07 HAZARDS ABATEMENT PLANS
008-HA-001	08-BUILDING 08 HAZARDS ABATEMENT PLANS
009-HA-001	09-BUILDING 09 HAZARDS ABATEMENT PLANS
010-HA-001	10-BUILDING 10 HAZARDS ABATEMENT PLANS
011-HA-001	11-BUILDING 11 HAZARDS ABATEMENT PLANS
012-HA-00A	12-BASEMENT HAZARDS ABATEMENT PLANS
012-HA-00B	12-BASEMENT SECTOR D HAZARDS ABATEMENT PLANS
012-HA-00A	12-GROUND FLOOR SECTOR A HAZARDS ABATEMENT PLANS
012-HA-00B	01-BASEMENT & FIRST FLOOR HAZARDS ABATEMENT PLANS
012-HA-00C	12-GROUND FLOOR SECTORS C&D HAZARDS ABATEMENT PLANS
012-HA-01A	12-FIRST FLOOR SECTOR A HAZARDS ABATEMENT PLANS
012-HA-01B	12-FIRST FLOOR SECTOR B HAZARDS ABATEMENT PLANS
012-HA-01C	12-FIRST FLOOR SECTORS C&D HAZARDS ABATEMENT PLANS
012-HA-02A	12-SECOND FLOOR SECTOR A HAZARDS ABATEMENT PLANS
012-HA-02B	12-SECOND FLOOR SECTOR B HAZARDS ABATEMENT PLANS
012-HA-02CD	12-SECOND FLOOR SECTORS C&D HAZARDS ABATEMENT PLANS
012-HA-03BCD	12-THIRD FLOOR HAZARDS ABATEMENT PLANS
012-HA-04	12-FOURTH FLOOR HAZARDS ABATEMENT PLANS
013-HA-011	13-BUILDING 13 HAZARDS ABATEMENT PLANS
014-HA-001	14-BUILDING 14 HAZARDS ABATEMENT PLANS
017-HA-011	14-BUILDING 14 HAZARDS ABATEMENT PLANS
018-HA-011	01-BASEMENT & FIRST FLOOR HAZARDS ABATEMENT PLANS
020-HA-001	20-BUILDING 20 HAZARDS ABATEMENT PLANS
023-HA-001	23-BUILDING 23 HAZARDS ABATEMENT PLANS
029-HA-001	29-BUILDING 29 HAZARDS ABATEMENT PLANS
043-HA-011	43-BUILDING 43 HAZARDS ABATEMENT PLANS
053-HA-001	53-BUILDING 53 HAZARDS ABATEMENT PLANS
065-HA-011	65-BUILDING 65 HAZARDS ABATEMENT PLANS
066-HA-011	66-BUILDING 66 HAZARDS ABATEMENT PLANS

MECHANICAL

SHEET NO. SHEET NAME

MK-001	MECHANICAL GENERAL INFORMATION
MK-002	MECHANICAL SITE PLAN
MK-003	DETAILS
MK-004	MECHANICAL SCHEDULES
MK-005	MECHANICAL CONTROLS INFORMATION
001-MD-001	01-BASEMENT HVAC DEMOLITION PLANS
001-MD-011	01-FIRST FLOOR HVAC DEMOLITION PLANS
001-MD-021	01-SECOND FLOOR HVAC DEMOLITION PLANS
001-MD-031	01-THIRD FLOOR HVAC DEMOLITION PLANS
002-MD-001	02-BASEMENT HVAC DEMOLITION PLANS
003-MD-011	03-FIRST FLOOR HVAC DEMOLITION PLANS
004-MD-001	04-HVAC DEMOLITION FLOOR PLANS
004-MD-002	04-ENLARGED HVAC DEMOLITION PLANS
005-MD-021	05-SECOND FLOOR HVAC DEMOLITION PLANS
006-MD-011	06-FIRST FLOOR HVAC DEMOLITION PLANS

VOLUME 2 - CONTINUED

SHEET NO. SHEET NAME

007-MD-011	07-FIRST FLOOR HVAC DEMOLITION PLANS
008-MD-011	08-FIRST FLOOR HVAC DEMOLITION PLANS
010-MD-001	10-BASEMENT HVAC DEMOLITION PLANS
011-MD-001	11-GROUND FLOOR HVAC DEMOLITION PLANS
012-MD-001	12-BASEMENT HVAC DEMOLITION PLANS - SECTOR A
012-MD-001	12-GROUND FLOOR HVAC DEMOLITION PLANS - SECTOR C/D
012-MD-011	12-FIRST FLOOR HVAC DEMOLITION PLANS - SECTOR A
012-MD-012	12-FIRST FLOOR HVAC DEMOLITION PLANS - SECTOR C/D
012-MD-021	12-SECOND FLOOR HVAC DEMOLITION PLANS - SECTOR C/D
012-MD-031	12-THIRD FLOOR HVAC DEMOLITION PLANS - SECTOR C/D
012-MD-041	12-FOURTH FLOOR HVAC DEMOLITION PLANS - SECTOR C/D
014-MD-001	14-GROUND FLOOR HVAC DEMOLITION PLANS
018-MD-011	18-FIRST FLOOR HVAC DEMOLITION PLANS
023-MD-001	23-BASEMENT HVAC DEMOLITION PLANS
053-MD-011	53-FIRST FLOOR HVAC DEMOLITION PLANS
065-MD-011	65-FIRST FLOOR HVAC DEMOLITION PLANS
001-MH-001	01-BASEMENT HVAC PLANS
001-MH-011	01-FIRST FLOOR HVAC PLANS
001-MH-021	01-SECOND FLOOR HVAC PLANS
001-MH-031	01-THIRD FLOOR HVAC PLANS
001-MH-041	01-ROOF HVAC PLANS
002-MH-001	02-BASEMENT HVAC PLANS
002-MH-021	02-SECOND FLOOR AND ROOF HVAC PLANS
003-MH-001	03-BASEMENT AND FIRST FLOOR HVAC PLANS
004-MH-001	04-HVAC FLOOR PLANS
004-MH-002	04-ENLARGED HVAC PLANS
005-MH-001	05-BASEMENT AND SECOND FLOOR HVAC PLANS
006-MH-001	06-BASEMENT AND FIRST FLOOR HVAC PLANS
007-MH-011	07-FIRST FLOOR HVAC PLANS
008-MH-011	08-FIRST FLOOR HVAC PLANS
010-MH-001	10-BASEMENT HVAC PLANS
011-MH-001	11-GROUND FLOOR HVAC PLANS
012-MH-001	12-BASEMENT HVAC PLANS - SECTOR A
012-MH-001	12-GROUND FLOOR HVAC PLANS - SECTOR A
012-MH-002	12-GROUND FLOOR HVAC PLANS - SECTOR C/D
012-MH-011	12-FIRST FLOOR HVAC PLANS - SECTOR A
012-MH-012	12-FIRST FLOOR HVAC PLANS - SECTOR C/D
012-MH-021	12-SECOND FLOOR HVAC PLANS - SECTOR A
012-MH-022	12-SECOND FLOOR HVAC PLANS - SECTOR C/D
012-MH-031	12-THIRD FLOOR HVAC PLANS - SECTOR C/D
012-MH-041	12-FOURTH FLOOR AND ROOF HVAC PLANS - SECTOR C/D
014-MH-001	14-GROUND FLOOR HVAC PLANS
018-MH-011	18-FIRST FLOOR AND MEZZANINE HVAC PLANS
023-MH-011	23-BASEMENT AND FIRST FLOOR HVAC PLANS
053-MH-011	53-FIRST FLOOR AND ROOF HVAC PLANS
065-MH-011	65-FIRST FLOOR HVAC PLANS
066-MH-011	66-FIRST FLOOR HVAC PLANS

END OF VOLUME 2

VOLUME 3

TELECOMMUNICATIONS

SHEET NO. SHEET NAME


00-GI-000.3	COVER SHEET VOLUME 3
00-GI-001	INDEX OF DRAWINGS
001-TD-001	TELECOM DEMOLITION PLAN -BLDG 1 BASEMENT
001-TD-011	TELECOM DEMOLITION PLAN -BLDG 1 FIRST FLOOR
001-TD-021	TELECOM DEMOLITION PLAN -BLDG 1 SECOND FLOOR
001-TD-031	TELECOM DEMOLITION PLAN -BLDG 1 THIRD FLOOR
002-TD-001	TELECOM DEMO PLAN -BLDG 2 SUB-BASEMENT/BASEMENT
002-TD-011	TELECOM DEMOLITION PLAN -BLDG 2 FIRST & SECOND FLOORS
002-TD-001	TELECOM DEMOLITION PLAN -BLDG 3 FLOOR LAYOUTS
005-TD-011	TELECOM DEMOLITION PLAN -BLDG 5
006-TD-001	TELECOM DEMOLITION PLANS -BLDG 6
006-TD-011	TELECOM DEMOLITION PLAN -BLDG 6 FIRST FLOOR
007-TD-001	TELECOM DEMOLITION PLAN -BLDG 7
007-TD-011	ENLARGED TELECOM DEMOLITION PLAN -BLDG 7
008-TD-001	TELECOM DEMOLITION PLAN -BLDG 8 BASEMENT
008-TD-011	TELECOM DEMOLITION PLAN -BLDG 8 FIRST & SECOND FLOOR
009-TD-001	TELECOM DEMOLITION PLAN -BLDG 9
010-TD-001	TELECOM DEMOLITION PLAN -BLDG 10
011-TD-001	TELECOM DEMOLITION PLAN -BLDG 11
012-TD-001	TELECOM DEMOLITION PLAN -BLDG 12 BASEMENT
012-TD-001A	TELECOM DEMO -BLDG 12 BASEMENT A ENLARGED
012-TD-001C	FILE A TELECOM DEMO -BLDG 12 BASEMENT C/D ENLARGED
012-TD-001	TELECOM DEMOLITION PLAN -BLDG 12 GROUND
012-TD-001A	TELECOM DEMO PLAN -BLDG 12 GROUND A ENLARGED
012-TD-001B	TELECOM DEMO PLAN -BLDG 12 GROUND B ENLARGED
012-TD-001C	TELECOM DEMO PLAN-BLDG 12 GROUND C/D ENLARGED
012-TD-011	TELECOM DEMOLITION PLAN -BLDG 12 FIRST FLOOR
012-TD-011A	TELECOM DEMO PLAN -BLDG 12 FIRST FLOOR A ENLARGED
012-TD-011B	TELECOM DEMO PLAN -BLDG 12 FIRST FLOOR B ENLARGED
012-TD-011C	TELECOM DEMO PLAN -BLDG 12 FIRST FLOOR C/D ENLARGED
012-TD-021	TELECOM DEMOLITION PLAN -BLDG 12 SECOND FLOOR
012-TD-021A	TELECOM DEMO PLAN -BLDG 12 SECOND FLOOR A ENLARGED
012-TD-021B	TELECOM DEMO PLAN -BLDG 12 SECOND FLOOR B ENLARGED
012-TD-021C	TELECOM DEMO PLAN -BLDG 12 SECOND FLOOR C/D ENLARGED
012-TD-031	TELECOM DEMOLITION PLAN -BLDG 12 THIRD FLOOR
012-TD-031B	TELECOM DEMO PLAN -BLDG 12 THIRD FLOOR B ENLARGED
012-TD-031C	TELECOM DEMO PLAN -BLDG 12 THIRD FLOOR C/D ENLARGED
012-TD-041	TELECOM DEMOLITION PLAN -BLDG 12 FOURTH FLOOR
013-TD-011	TELECOM DEMOLITION PLAN -BLDG 13 FIRST FLOOR
014-TD-001	TELECOM DEMOLITION PLAN -BLDG 14
017-TD-011	TELECOM DEMOLITION PLAN -BLDG 17 FIRST FLOOR
018-TD-011	TELECOM DEMOLITION PLAN -BLDG 18
020-TD-011	TELECOM DEMOLITION PLAN -BLDG 20
023-TD-001	TELECOM DEMOLITION PLAN -BLDG 23
029-TD-001	TELECOM DEMOLITION PLAN -BLDG 29
043-TD-011	TELECOM DEMOLITION PLAN -BLDG 43
053-TD-001	TELECOM DEMOLITION PLAN -BLDG 53
065-TD-011	TELECOM DEMOLITION PLAN -BLDG 65
066-TD-012	ENLARGED TELECOM DEMOLITION PLAN -ROOM 109
066-TD-011	TELECOM DEMOLITION PLAN -BLDG 66
TJ-001	GENERAL TELECOM NOTES
TK-101	TELEPHONE BACKBONE CABLING PLAN
TK-102	TELECOM SCHEDULES
TK-103	VOICE GATEWAY 1 SCHEDULE
TK-104	VOICE GATEWAY 2 SCHEDULE
TK-105	VOICE GATEWAY 3 SCHEDULE
TK-106	TELECOM DUCT/BANK AND MAN HOLE ONE LINE
TK-107	DUCT BANK SCHEDULE
TK-108	PATCH PANEL SCHEDULES

VOLUME 3 - CONTINUED

SHEET NO. SHEET NAME

TK-109	PATCH PANEL SCHEDULES
TK-110	PATCH PANEL SCHEDULES
TK-111	PATCH PANEL SCHEDULES
TK-112	PATCH PANEL SCHEDULES
TK-113	PATCH PANEL SCHEDULES
TK-114	PATCH PANEL SCHEDULES
TK-115	PATCH PANEL SCHEDULES
TK-116	PATCH PANEL SCHEDULES
TK-117	PATCH PANEL SCHEDULES
TK-118	PATCH PANEL SCHEDULES
TK-119	PATCH PANEL SCHEDULES
TK-120	PATCH PANEL SCHEDULES
TK-121	PATCH PANEL SCHEDULES
TK-122	PATCH PANEL SCHEDULES
TK-123	PATCH PANEL SCHEDULES
TK-124	PATCH PANEL SCHEDULES
TK-125	PATCH PANEL SCHEDULES
TK-126	TELECOM GROUNDING DETAILS
TK-127	TELECOM GROUNDING DETAILS
TK-128	FIBER SITE REMODEL ONE LINE-PRIMARY PATHWAYS
TK-129	FIBER SITE REMODEL ONE LINE-SECONDARY PATHWAYS
TK-130	ANALOG SITE REMODEL
TK-131	TELECOM RACK BONDING DETAILS
TK-132	TELECOM RACK BONDING DETAILS
TK-133	TELECOM RACK BONDING DETAILS
TK-134	TELECOM DETAILS
TK-135	NEW PATCH PANEL SCHEDULE -BLDG 1
TK-136	NEW PATCH PANEL SCHEDULE -BLDG 1 & 2
TK-137	NEW PATCH PANEL SCHEDULE -BLDG 3 & 5
TK-138	NEW PATCH PANEL SCHEDULE -BLDG 6, 7, 8, & 11
TK-139	NEW

1. DEMOLISH ELECTRICAL SYSTEMS IN ENCLOSED STAIRCASE. SALVAGE LOCAL LIGHTING CIRCUIT FOR EXTENSION TO NEW LOCATION.

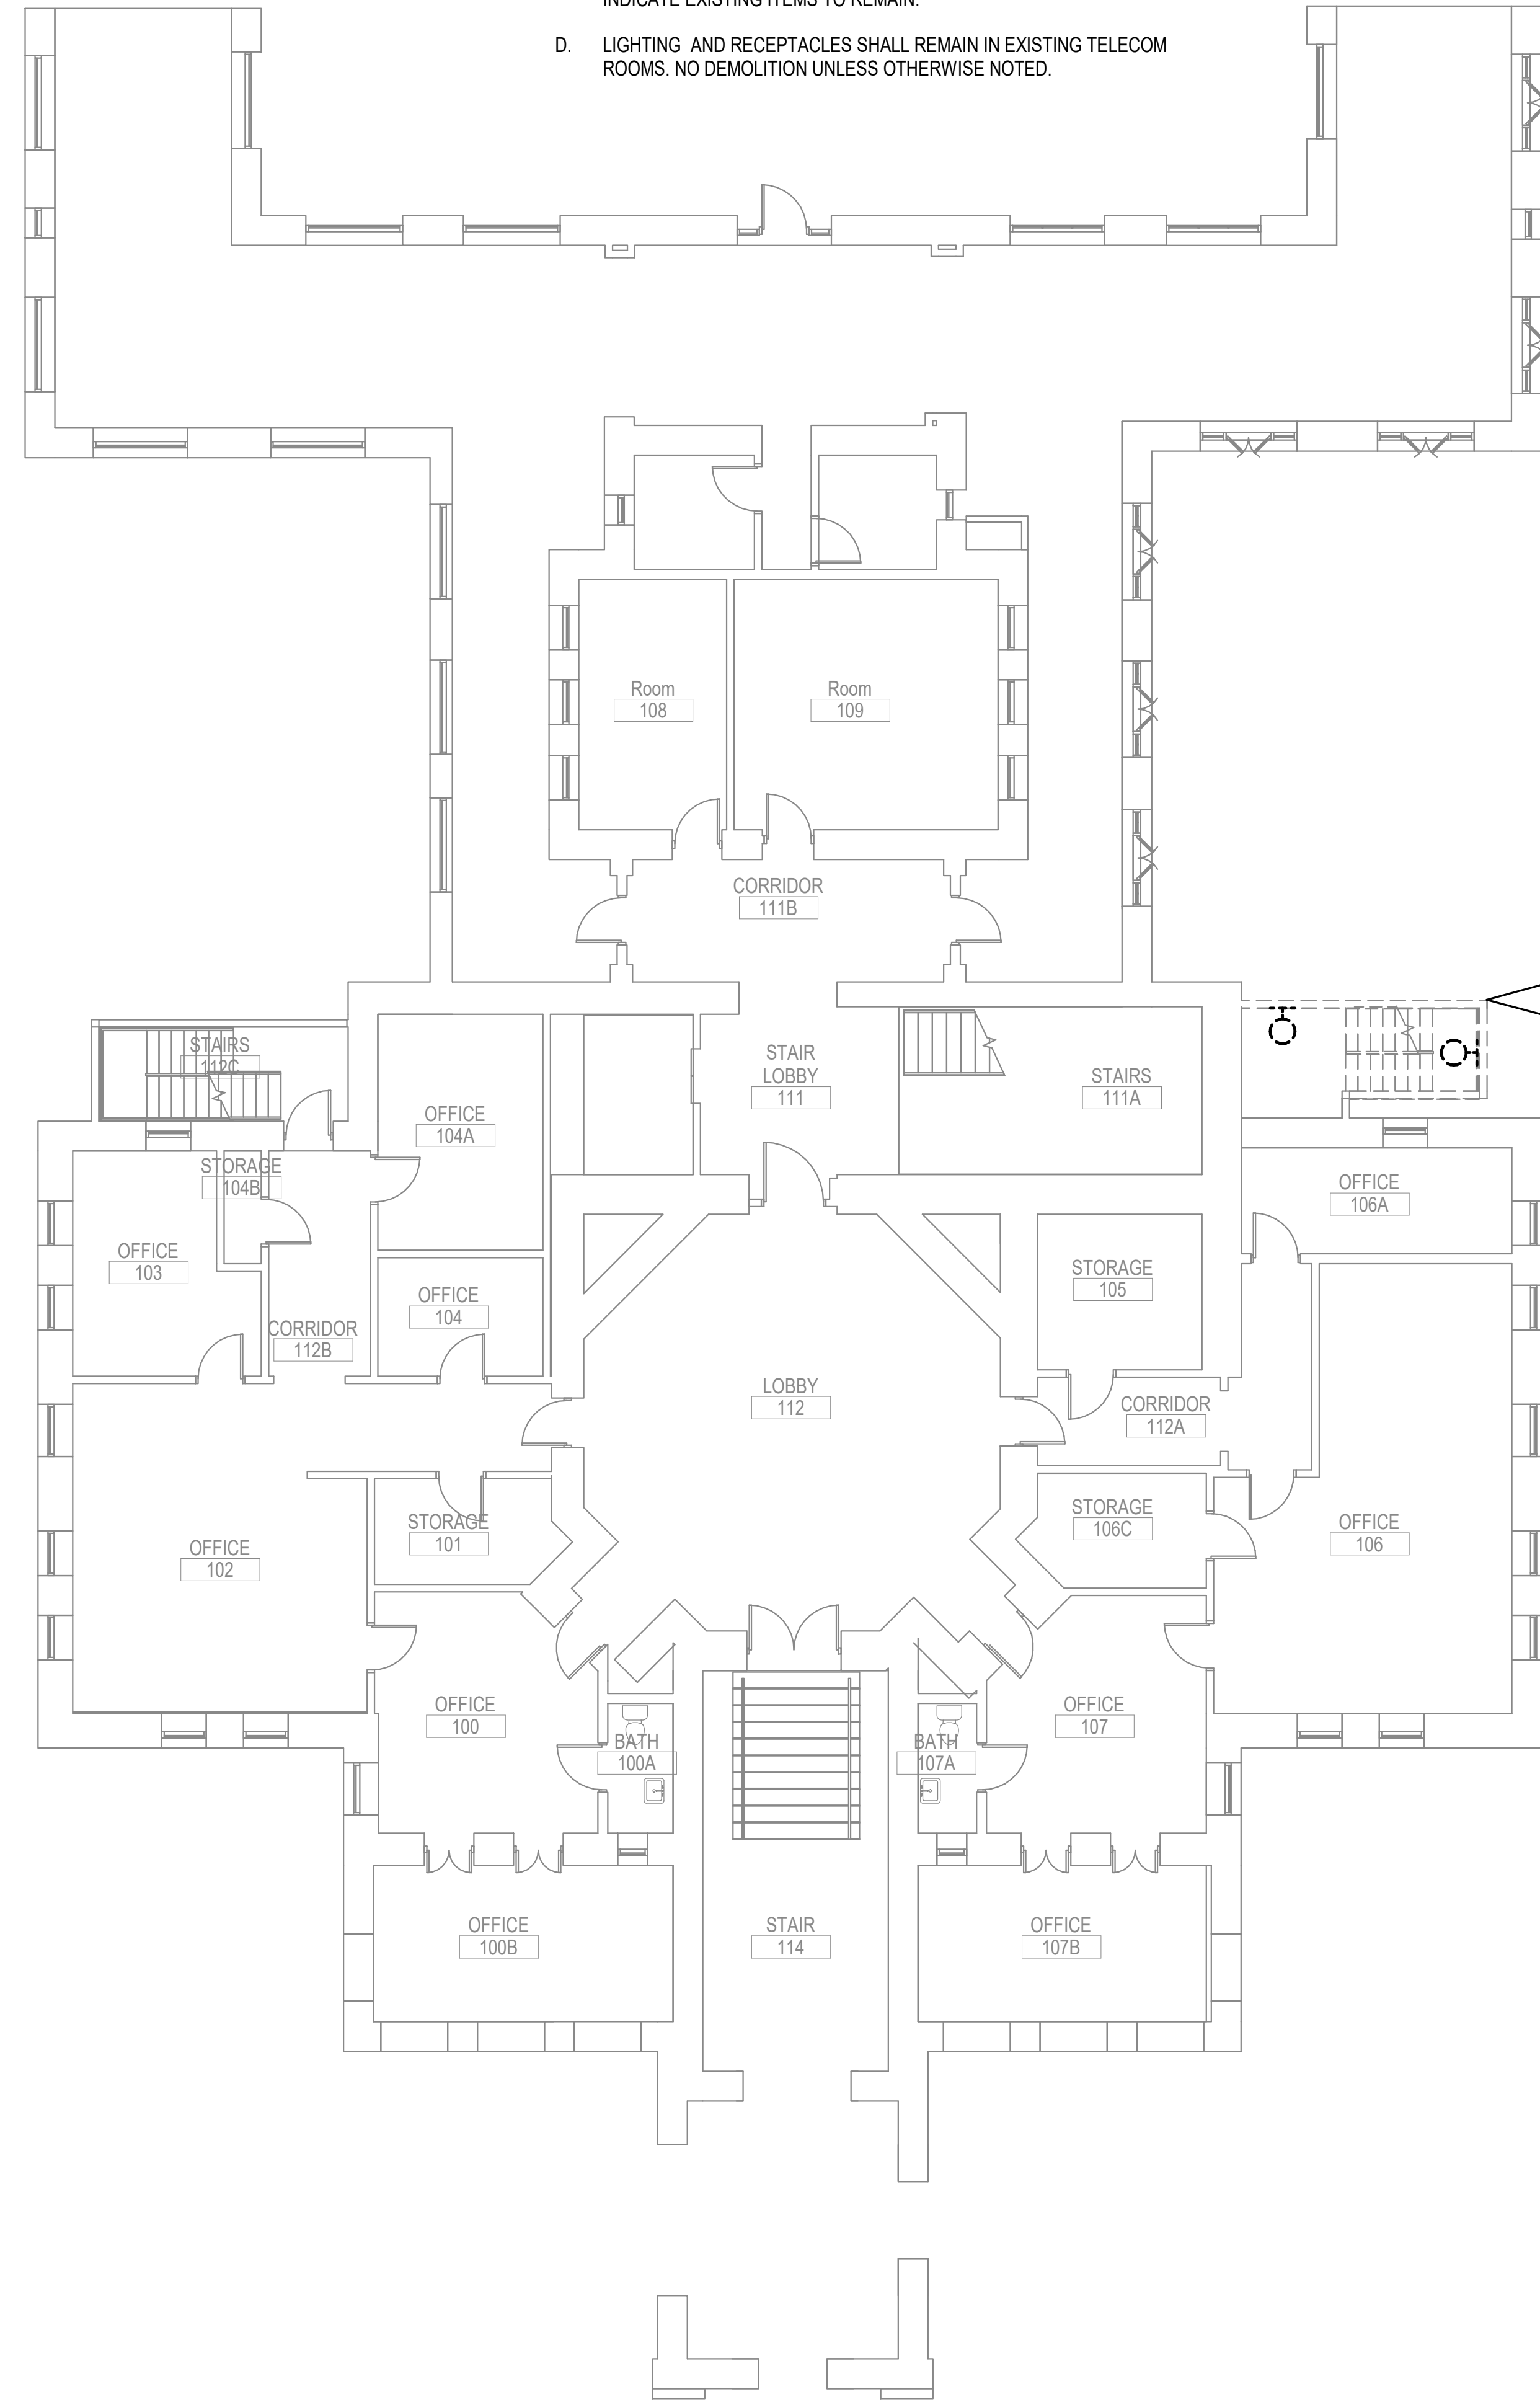

PLAN
NORTH

PROJECT NUMBER
568A4-21-702
BUILDING NUMBER
N/A
DRAWING NUMBER
001-ED-0B1

A

B

C

D

E

F

2/22/2022 5:22:28 PM
C:\Users\Caleb\AppData\Local\Microsoft\REVIT\2020\LOCAL\SM1121\ESERIES_BLDG_1\201_4.dwg (OPENED)

2/22/2022 5:22:28 PM
C:\Users\Caleb\AppData\Local\Microsoft\REVIT\2020\LOCAL\SM1121\ESERIES_BLDG_1\201_4.dwg (OPENED)

A

B

C

D

 
E

F


GENERAL NOTES:

- A. THE INFORMATION SHOWN ON THIS DRAWING IS TAKEN FROM RECORD DRAWINGS AND A NON-DESTRUCTIVE WALK THROUGH OF THE FACILITY. THERE IS NO WARRANTY OR GUARANTEE AS TO THE ACCURACY OF THE INFORMATION SHOWN HERE-IN. THE CONTRACTOR SHALL FIELD VERIFY ALL ITEMS SCHEDULED FOR DEMOLITION PRIOR TO START OF WORK.
- B. THE OWNER SHALL HAVE FIRST RIGHT OF REFUSAL ON ALL SALVAGEABLE MATERIALS. THE CONTRACTOR SHALL DELIVER SALVAGED MATERIALS TO A WAREHOUSE AS DIRECTED BY THE OWNER. THE CONTRACTOR SHALL DISPOSE OF, OFF SITE, ALL UNWANTED MATERIALS.
- C. DASHED OR DOTTED LINES INDICATE ITEMS TO BE REMOVED. SOLID LINES INDICATE EXISTING ITEMS TO REMAIN.
- D. LIGHTING AND RECEPTACLES SHALL REMAIN IN EXISTING TELECOM ROOMS. NO DEMOLITION UNLESS OTHERWISE NOTED.


SHEET NOTES:



1. DEMOLISH ELECTRICAL SYSTEMS IN ENCLOSED STAIRCASE. SALVAGE LOCAL LIGHTING CIRCUIT FOR EXTENSION TO NEW LOCATION.

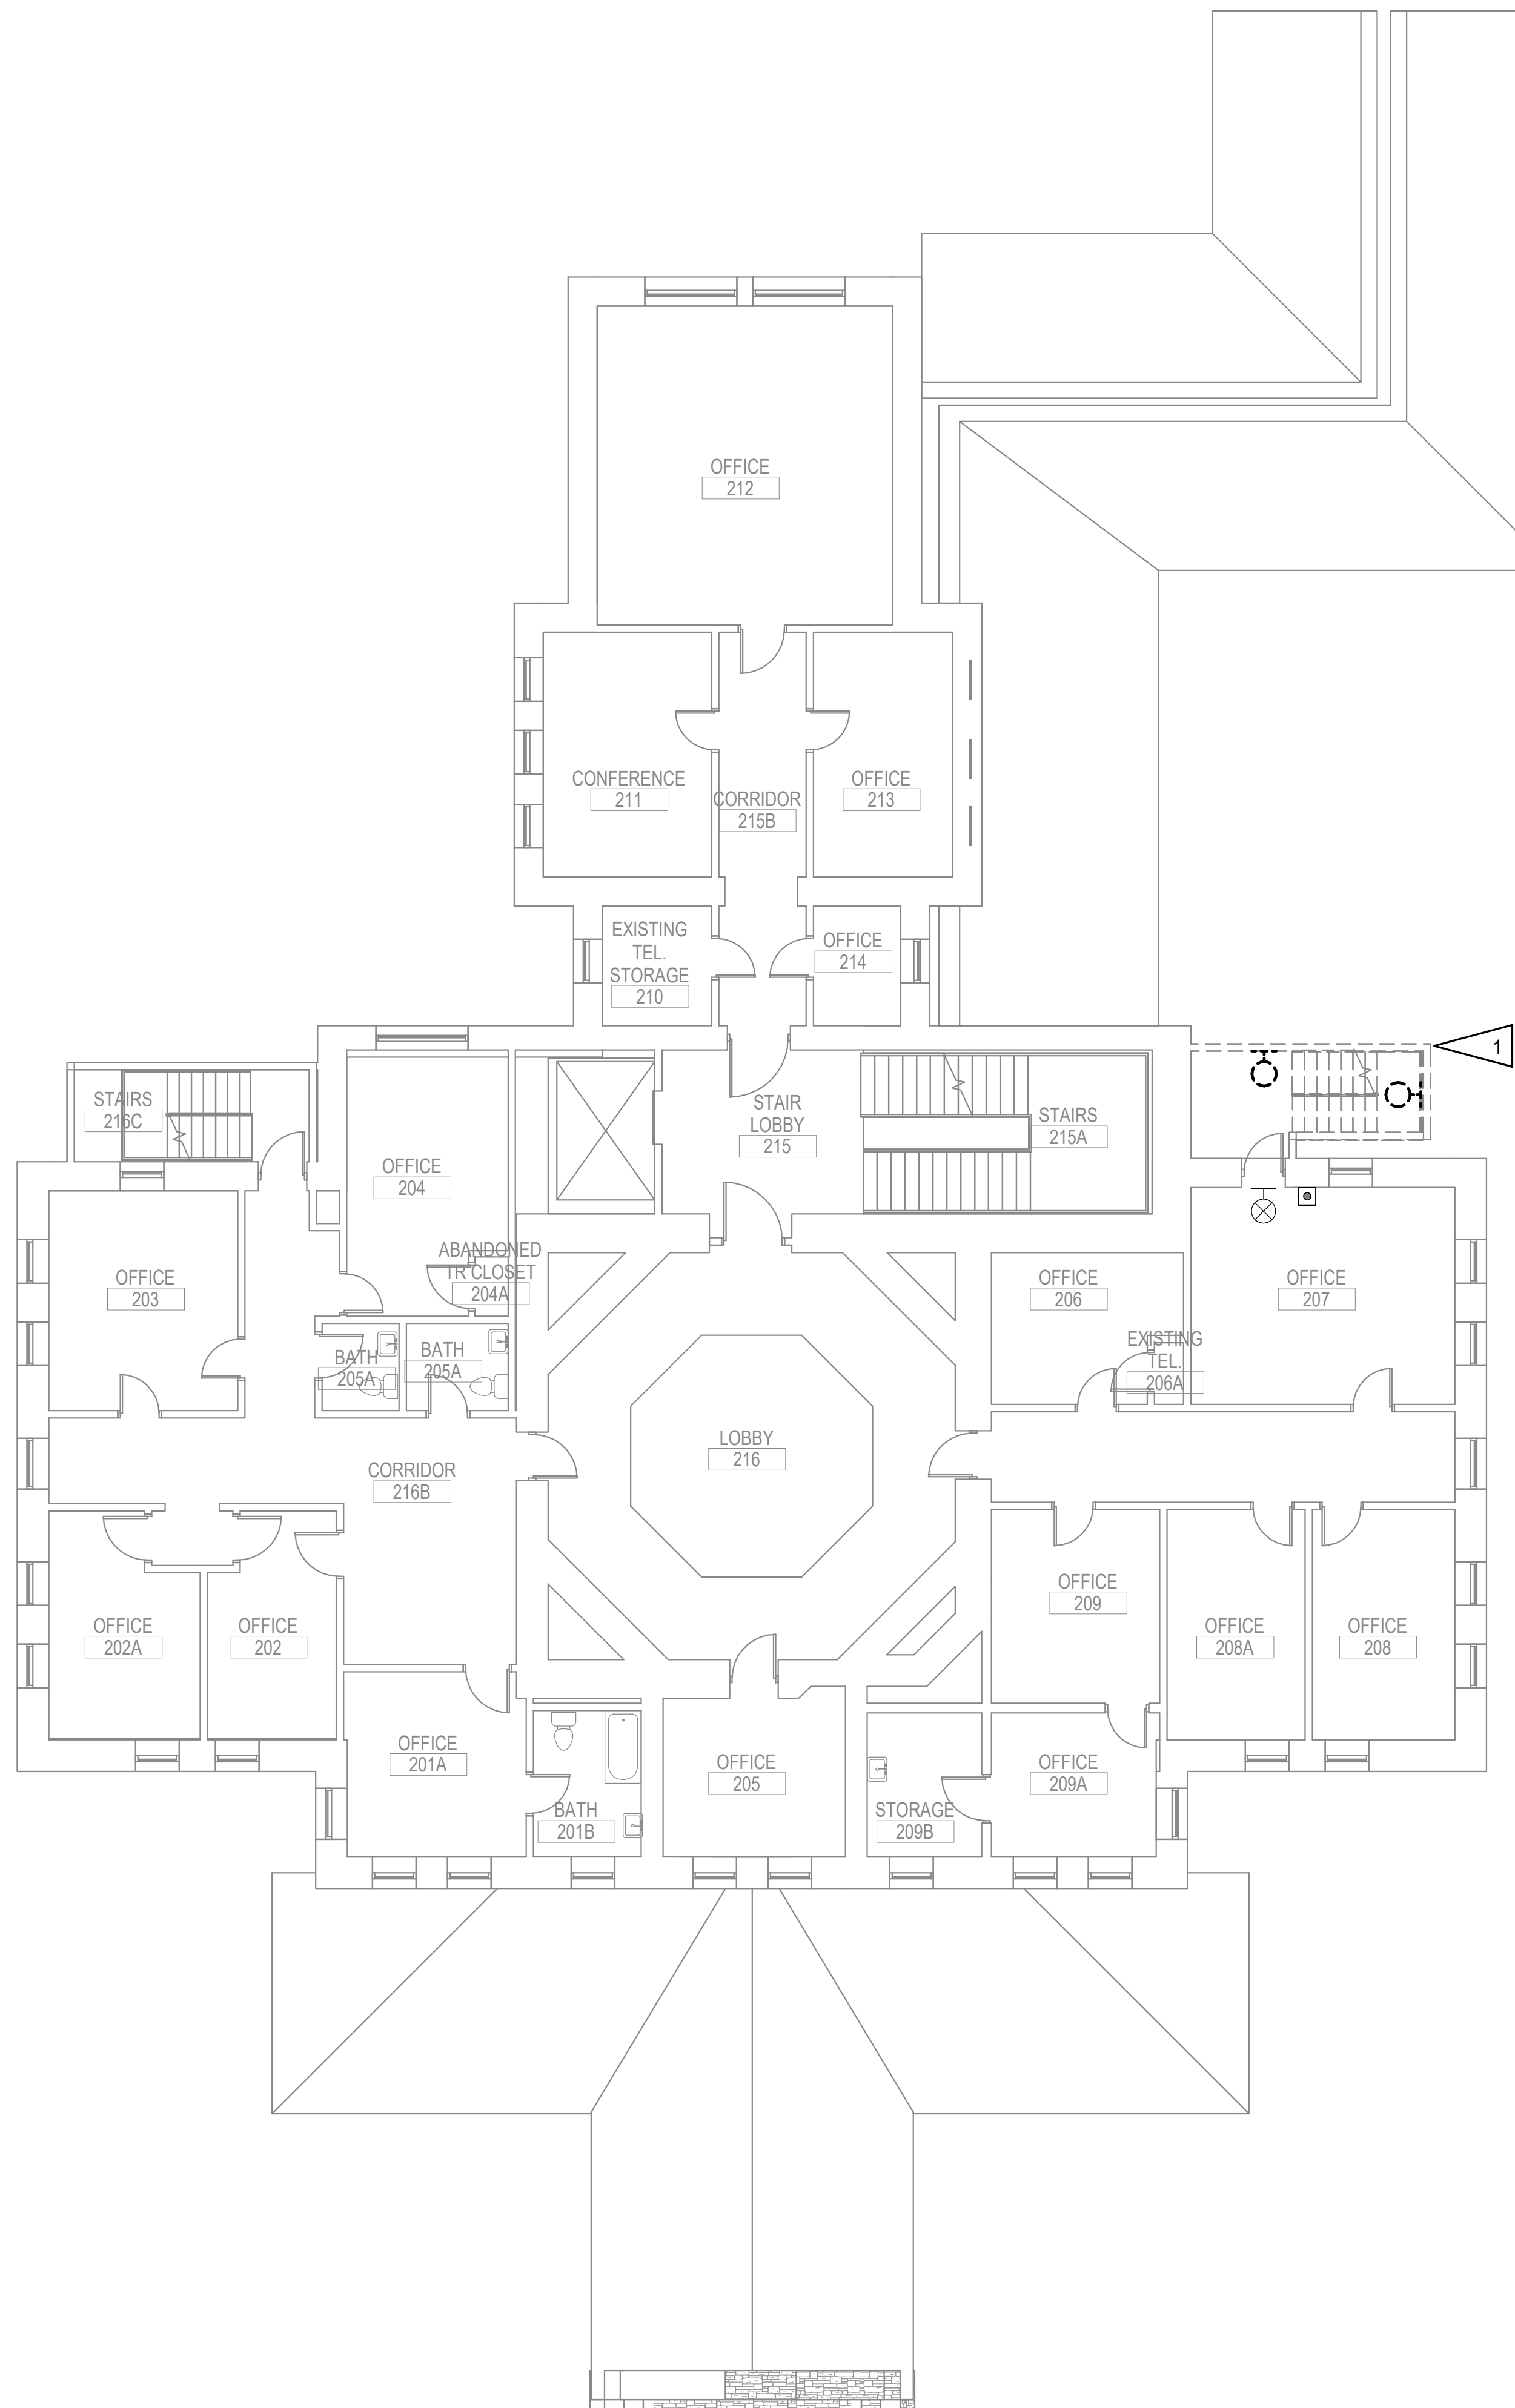


1 ELECTRICAL DEMOLITION PLAN - BLDG 1 SECOND FLOOR
1/8" = 1'-0"

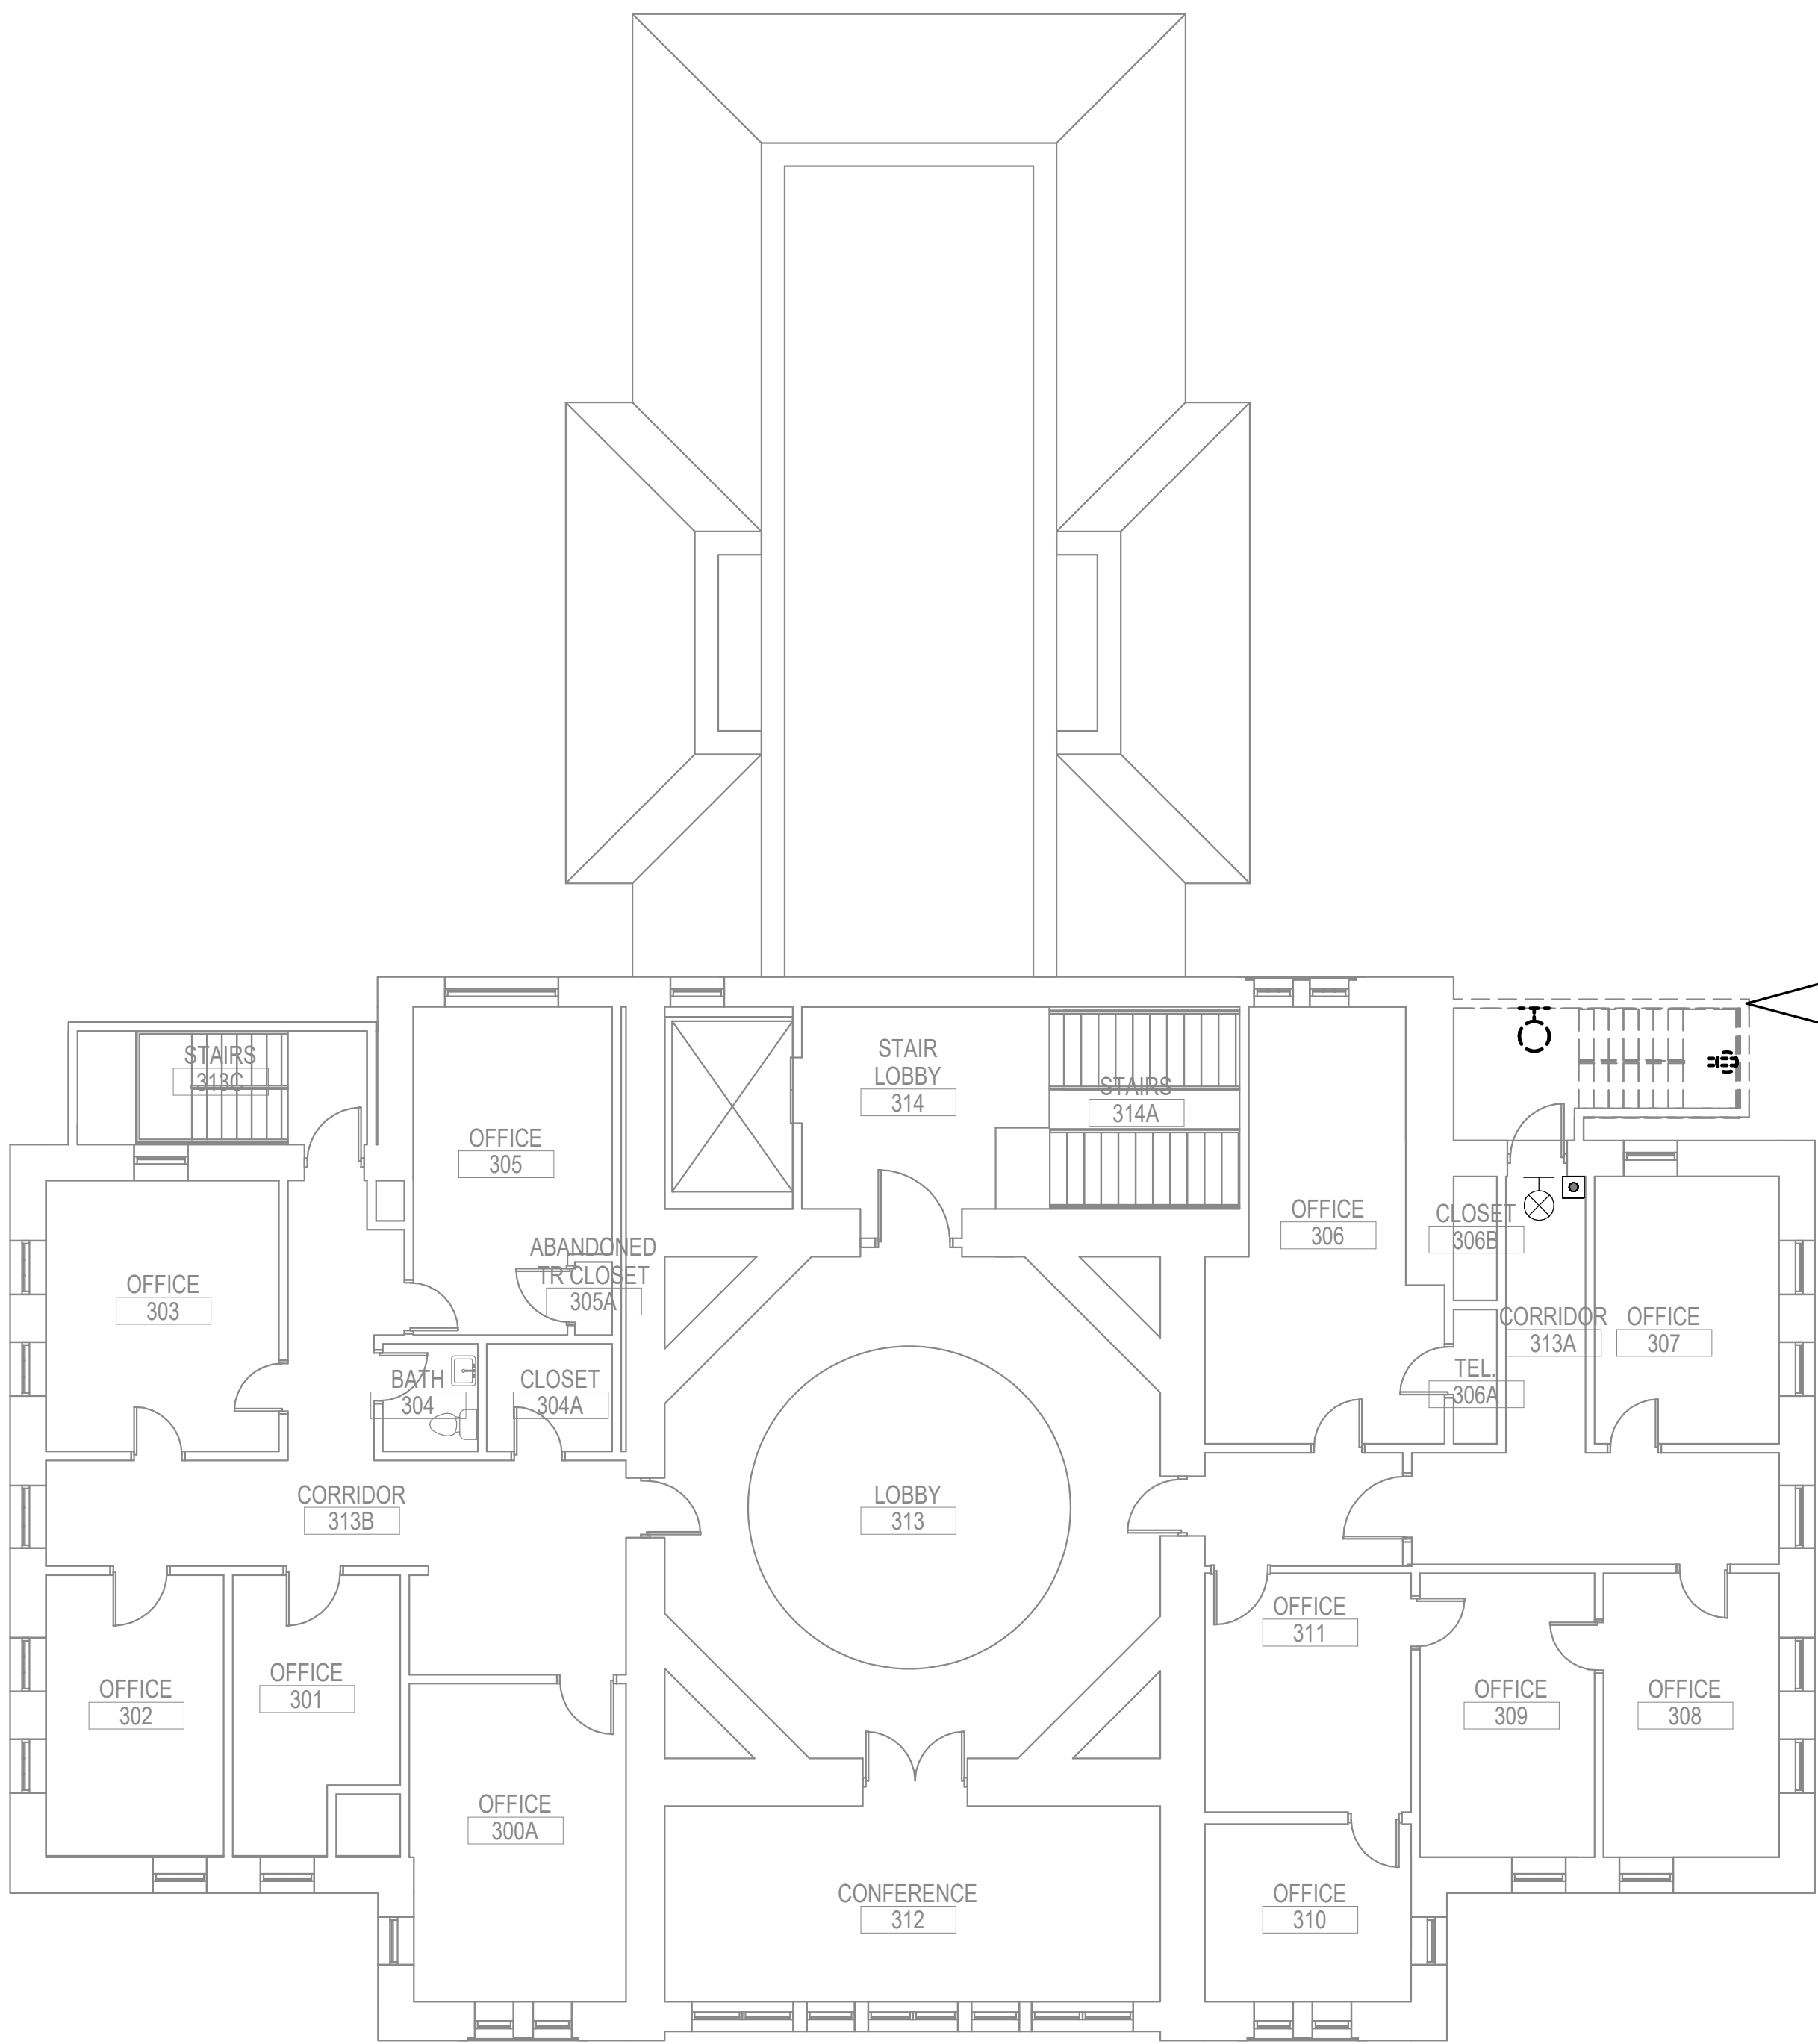

2 ELECTRICAL DEMOLITION PLAN - BLDG 1 THIRD FLOOR
1/8" = 1'-0"



SITE LEGEND

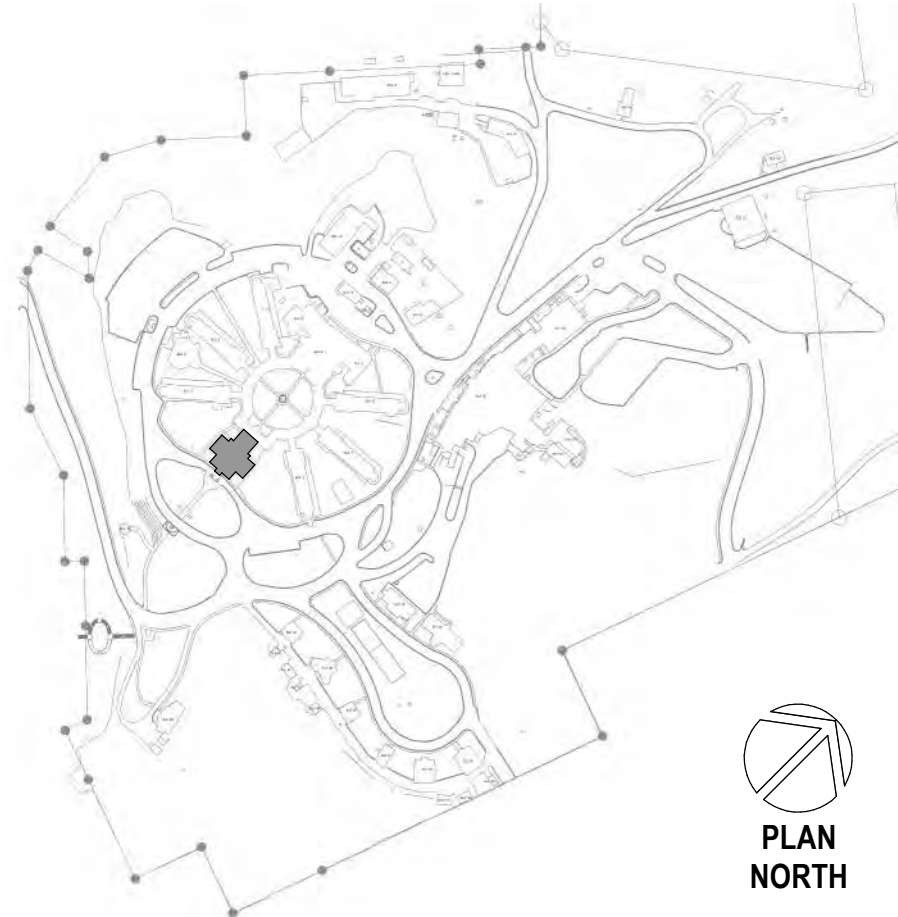

Revisions:	Date:

CONSULTANT

A/E:
GDM
1000 W STEUBEN STR, UNIT 3
BINGEN, WA 98605
541.436.4723
ADAM GOODIN, PE

GDM
ARCHITECTS • ENGINEERS

ARCHITECT/ENGINEER OF RECORD

RSA
Engineering, Inc.
MECHANICAL AND ELECTRICAL CONSULTING ENGINEERS
670 West Firwood Lane, Suite 200
Anchorage, AK 99503
Phone (907) 278-0521
Corporate No.: AEC0542

STAMP

STATE OF ALASKA
JEREMY A. MAXIE
REGISTERED PROFESSIONAL ENGINEER
No. 113847
EXPIRES 12/31/2024

PROGRAM CONTRACTING ACTIVITY CENTRAL (PCAC)

VA U.S. Department of Veterans Affairs

DRAWING TITLE
ELECTRICAL DEMOLITION PLAN - BLDG 1 SECOND & THIRD FLOOR

APPROVED: Project Director

PHASE
100% CD FINAL SOLUTION

FLS
FULLY SPRINKLERED

PROJECT TITLE
EHRM INFRASTRUCTURE UPGRADES

LOCATION
HOT SPRINGS, SOUTH DAKOTA

ISSUE DATE
02/22/2022

CHECKED BY
JAM

DRAWN BY
CSZ

PROJECT NUMBER
568A4-21-702

BUILDING NUMBER
N/A

DRAWING NUMBER
001-ED-021

A

B

C


D

E



F

2/22/2022 3:38:15 PM

C:\Users\Caleb\AppData\Local\Microsoft\OneDrive\OneDrive\Documents\REVIT 2020\LOCALS\MM121\ESERIES_BLDG 2\02_40pp02ETM.rvt

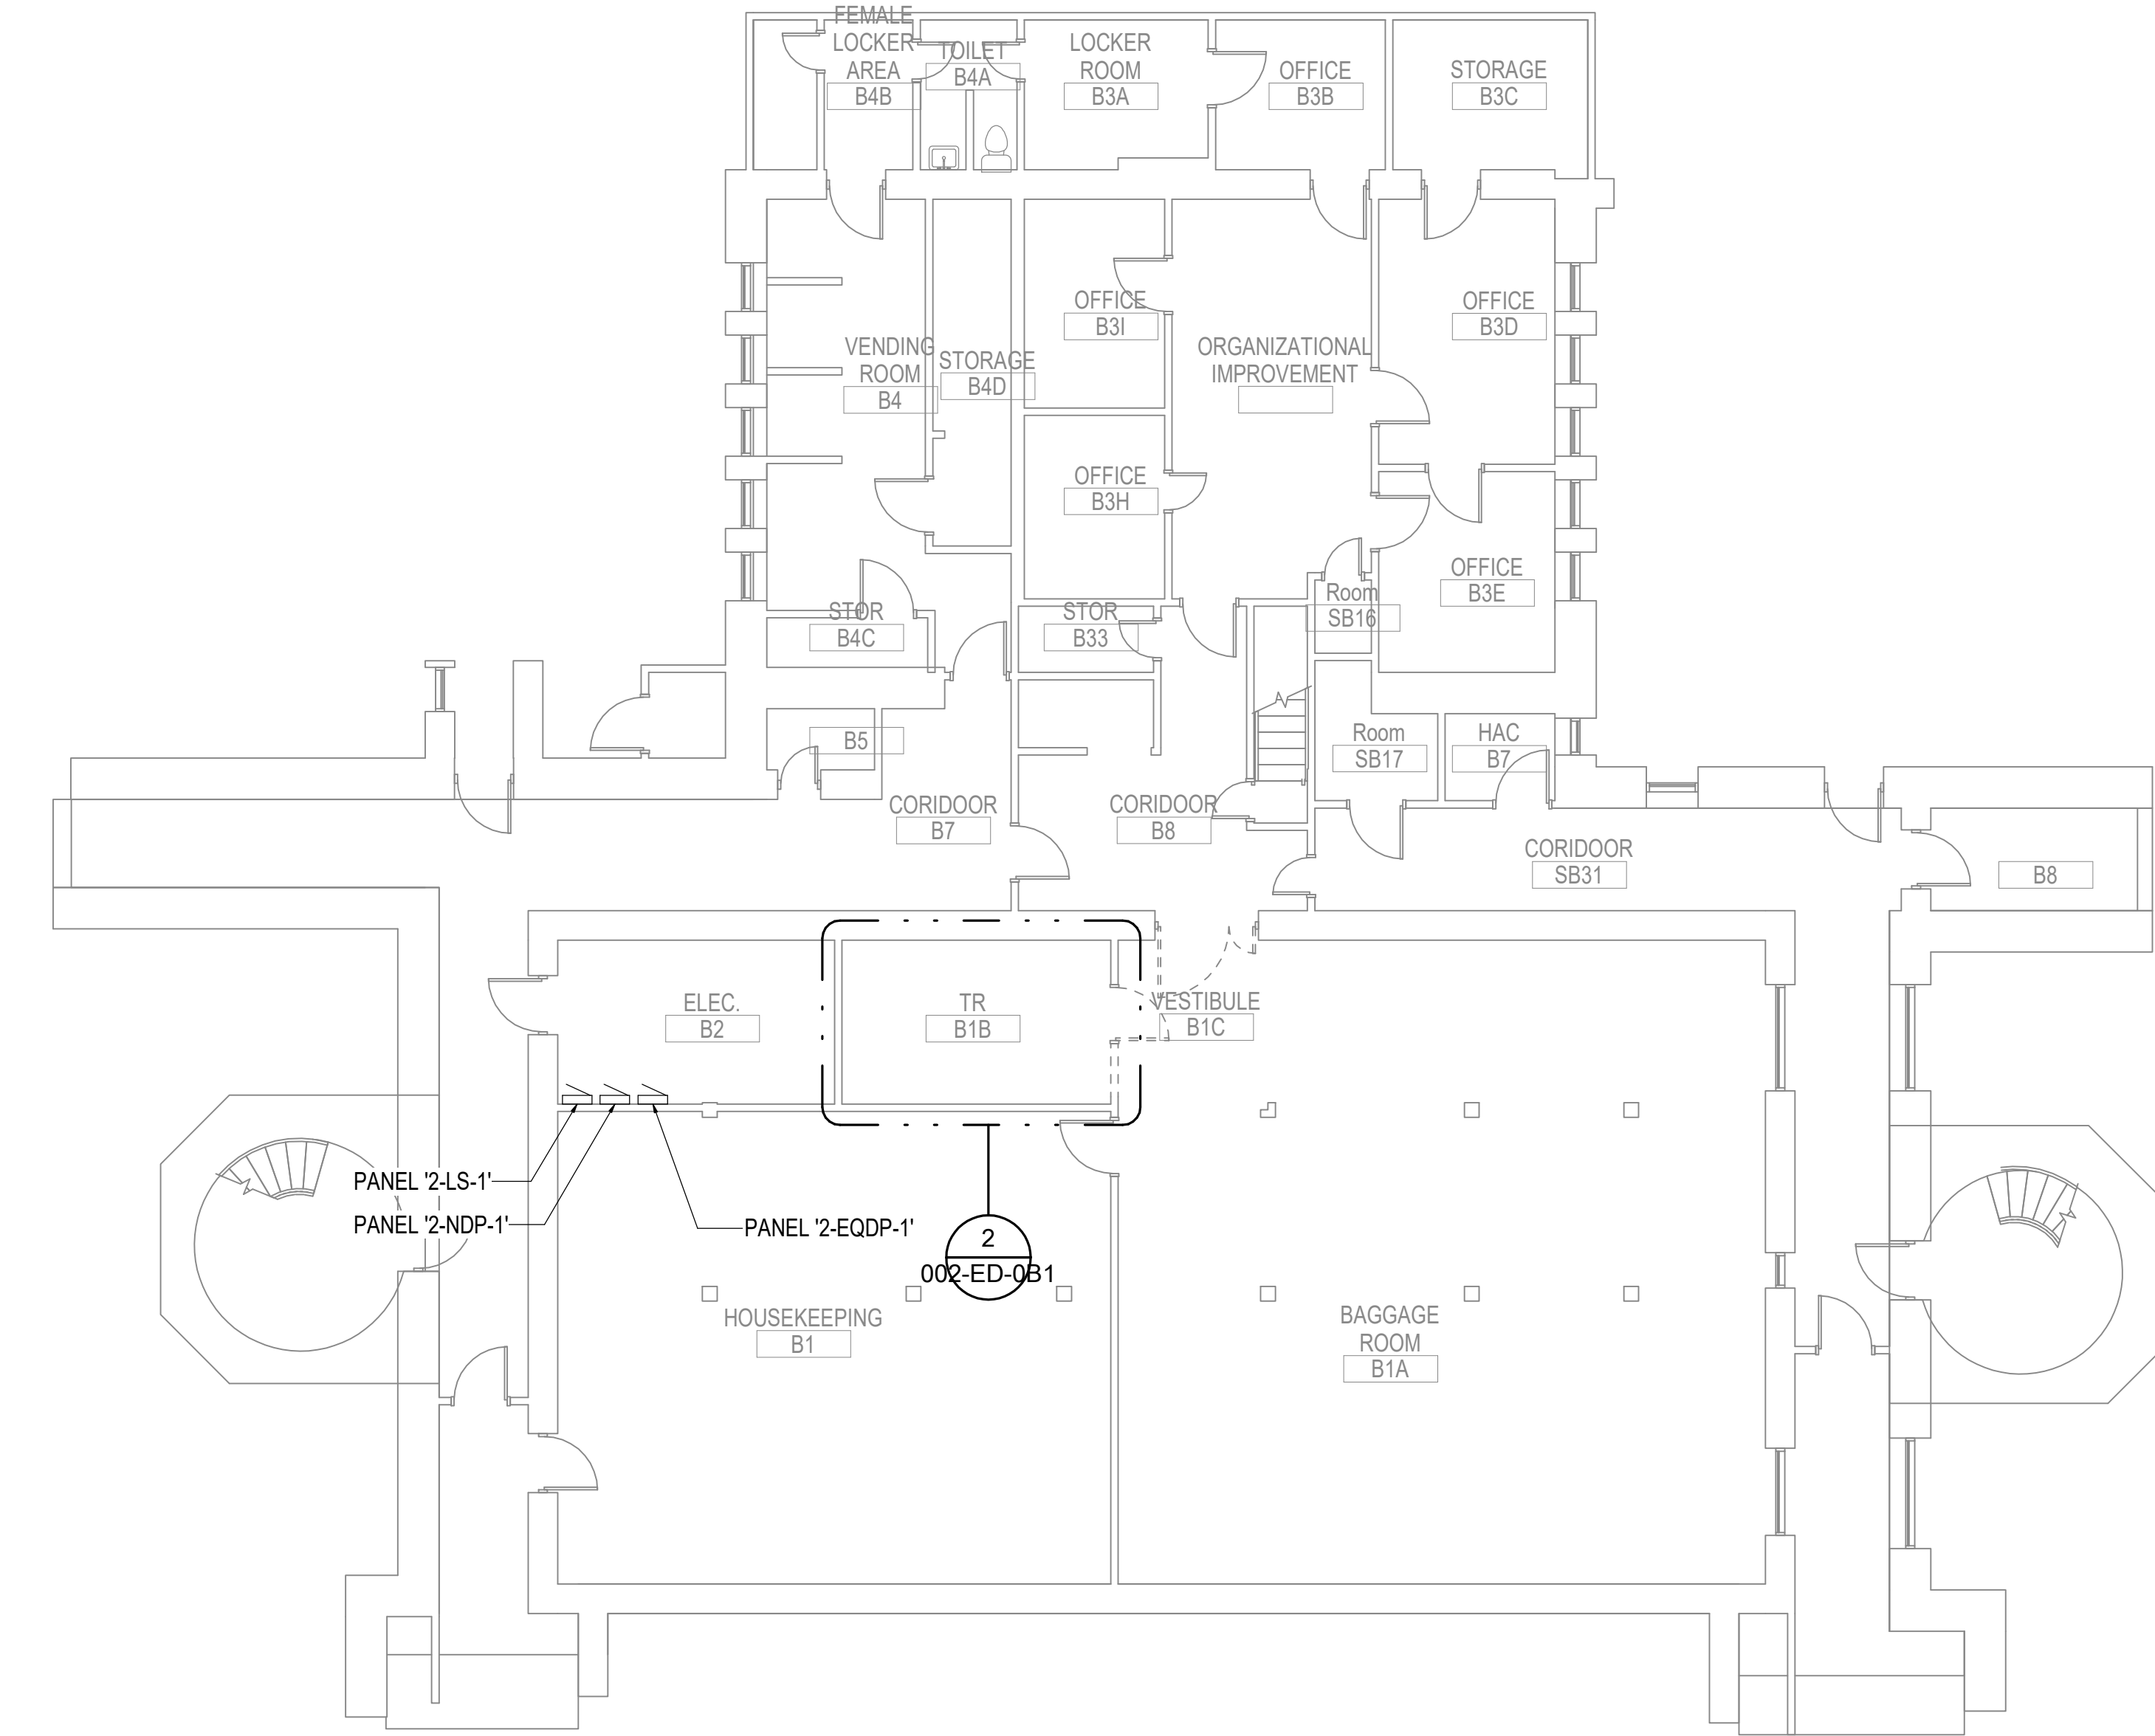


1 ELECTRICAL DEMOLITION PLAN - BLDG 2 BASEMENT
1/8" = 1'-0"

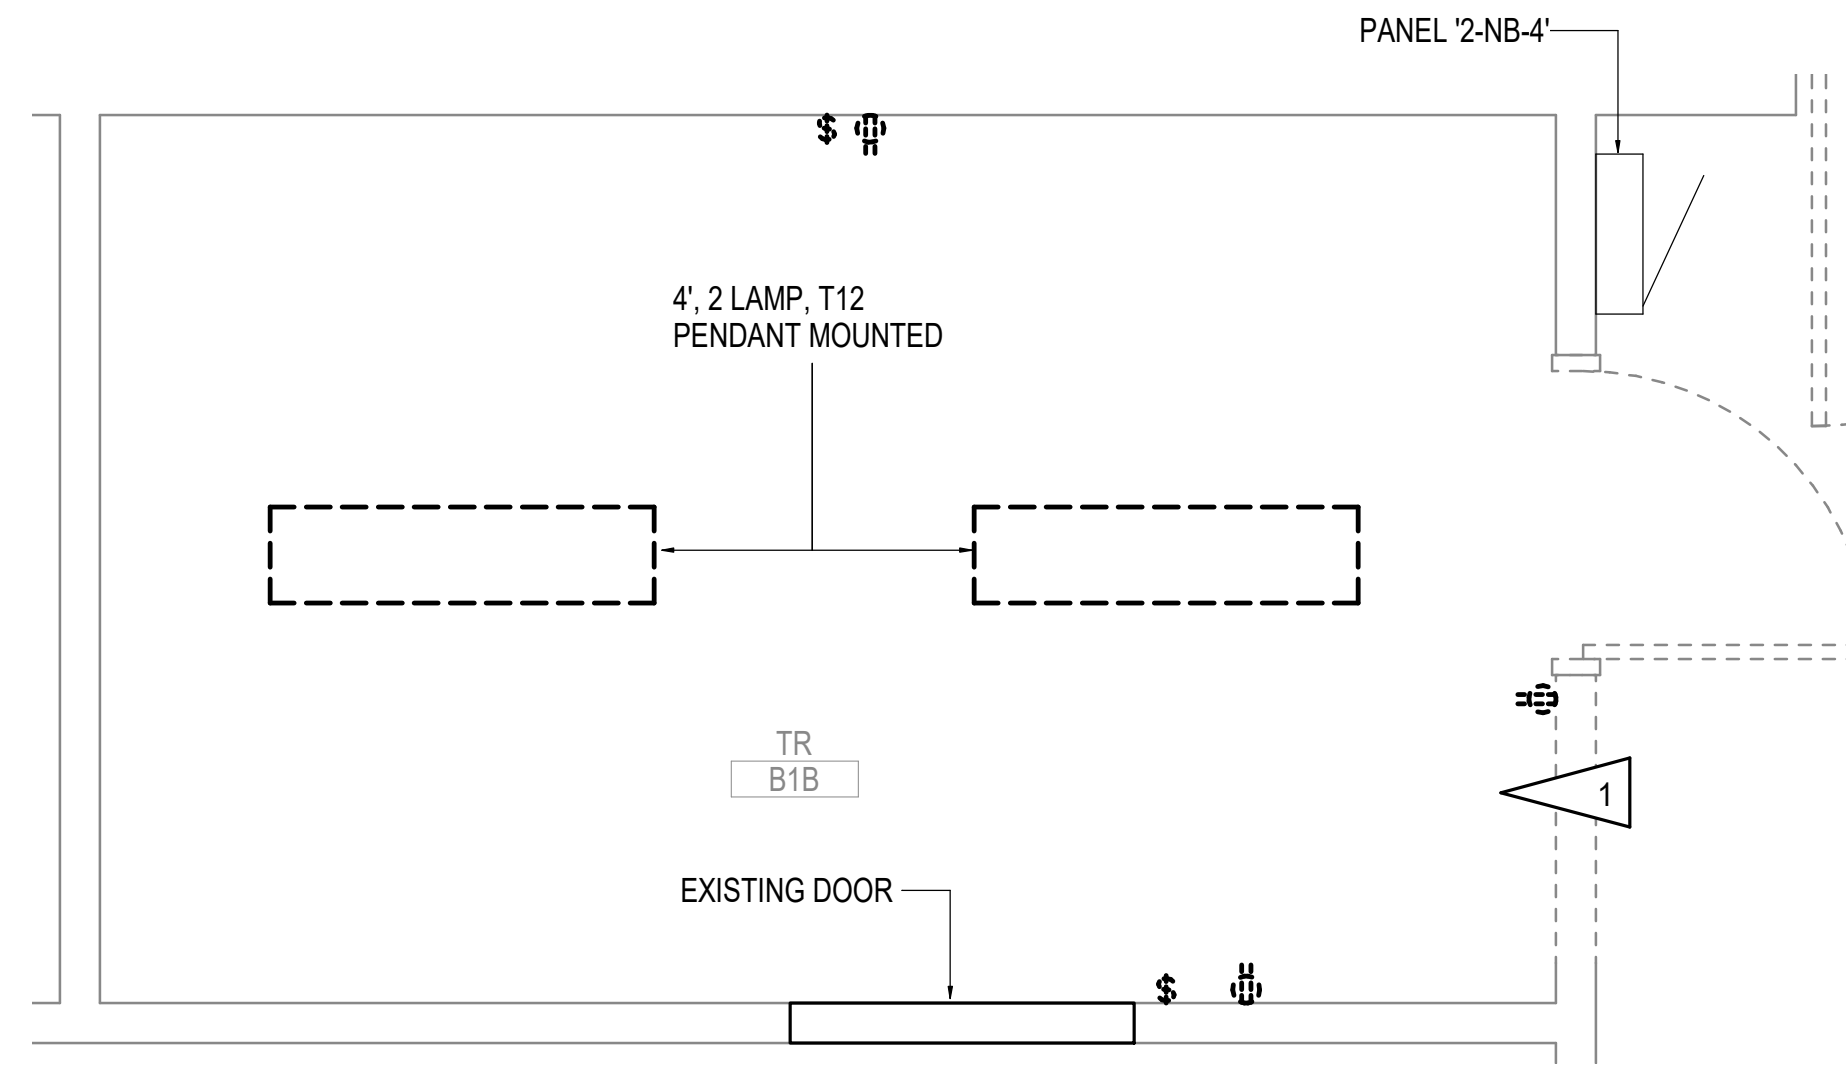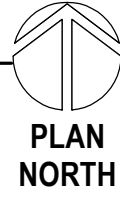

2 ENLARGED ROOM - B1B ELECTRICAL DEMOLITION
1/2" = 1'-0"



SITE LEGEND

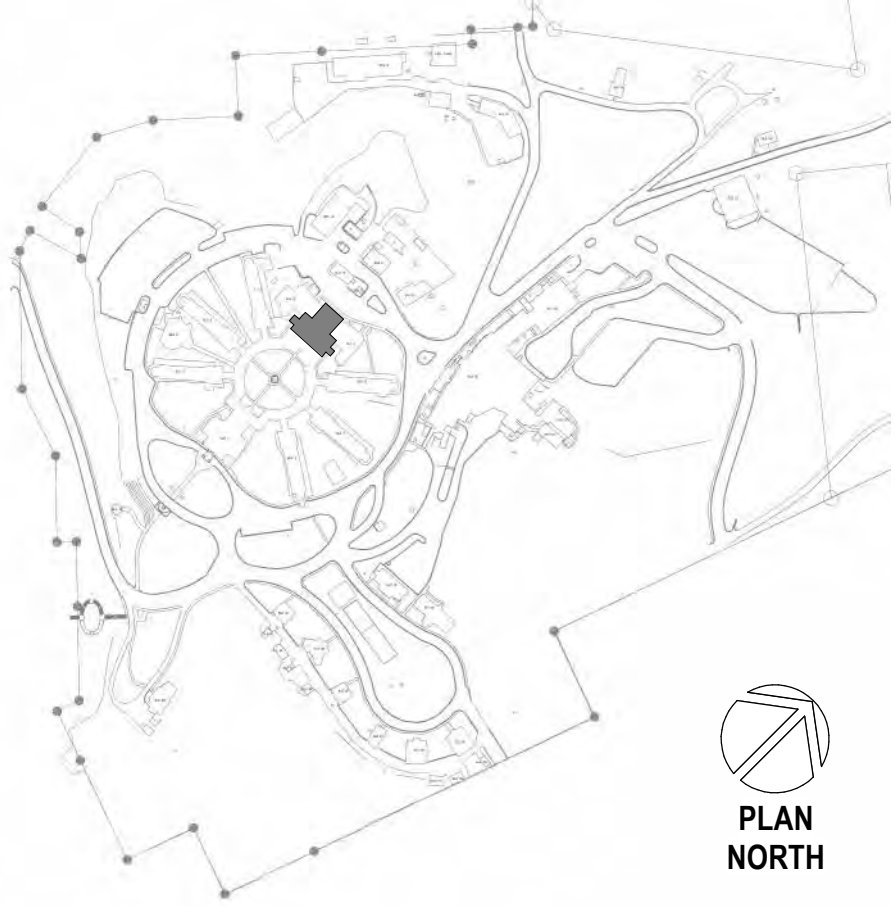

PLAN NORTH

A

B

C

D


E

F

CONSULTANT	
A/E:	GDM
	1000 W STEUBEN ST, UNIT 3
	BINGEN, WA 98605
	541.436.4723
	ADAM GOODIN, PE
Revisions:	Date:



ARCHITECT/ENGINEER OF RECORD	
RSA	Engineering, Inc.
MECHANICAL AND ELECTRICAL CONSULTING ENGINEERS	
670 West Firwood Lane, Suite 200	
Anchorage, AK 99503	
Phone (907) 278-0521	
Corporate No.: AECC542	

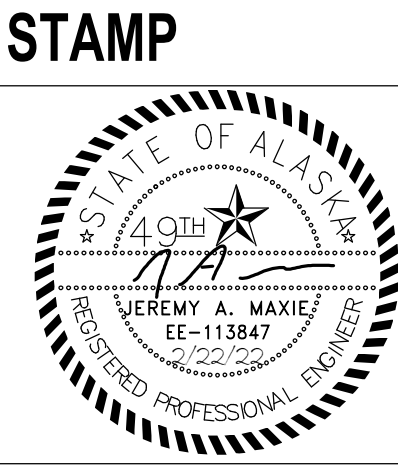

PROGRAM CONTRACTING ACTIVITY CENTRAL (PCAC)	
VA	U.S. Department of Veterans Affairs

DRAWING TITLE	
ELECTRICAL DEMOLITION PLAN - BLDG 2 BASEMENT	
APPROVED: Project Director	

PHASE	
100% CD FINAL SOLUTION	
FLS	
FULLY SPRINKLERED	

PROJECT TITLE	
EHRM INFRASTRUCTURE UPGRADES	
LOCATION	
HOT SPRINGS, SOUTH DAKOTA	
ISSUE DATE	
2/22/2022	
CHECKED BY	
JAM	
DRAWN BY	
CSZ	


PROJECT NUMBER	
568A4-21-702	
BUILDING NUMBER	
02	
DRAWING NUMBER	
002-ED-0B1	

C:\Users\Caleb\AppData\Local\Microsoft\Windows\Temporary Internet Files\Content.IE5\B301G6T6\002-ED-021.dwg
2/22/2022 5:39:12 PM


C:\Users\Caleb\AppData\Local\Microsoft\Windows\Temporary Internet Files\Content.IE5\B301G6T6\002-ED-021.dwg
2/22/2022 5:39:12 PM

GENERAL NOTES:

- A. THE INFORMATION SHOWN ON THIS DRAWING IS TAKEN FROM RECORD DRAWINGS AND A NON-DESTRUCTIVE WALK THROUGH OF THE FACILITY. THERE IS NO WARRANTY OR GUARANTEE AS TO THE ACCURACY OF THE INFORMATION SHOWN HERE-IN. THE CONTRACTOR SHALL FIELD VERIFY ALL ITEMS SCHEDULED FOR DEMOLITION PRIOR TO START OF WORK.
- B. THE OWNER SHALL HAVE FIRST RIGHT OF REFUSAL ON ALL SALVAGEABLE MATERIALS. THE CONTRACTOR SHALL DELIVER SALVAGED MATERIALS TO A WAREHOUSE AS DIRECTED BY THE OWNER. THE CONTRACTOR SHALL DISPOSE OF, OFF SITE, ALL UNWANTED MATERIALS.
- C. DASHED OR DOTTED LINES INDICATE ITEMS TO BE REMOVED. SOLID LINES INDICATE EXISTING ITEMS TO REMAIN.
- D. LIGHTING AND RECEPTACLES SHALL REMAIN IN EXISTING TELECOM ROOMS. NO DEMOLITION UNLESS OTHERWISE NOTED.

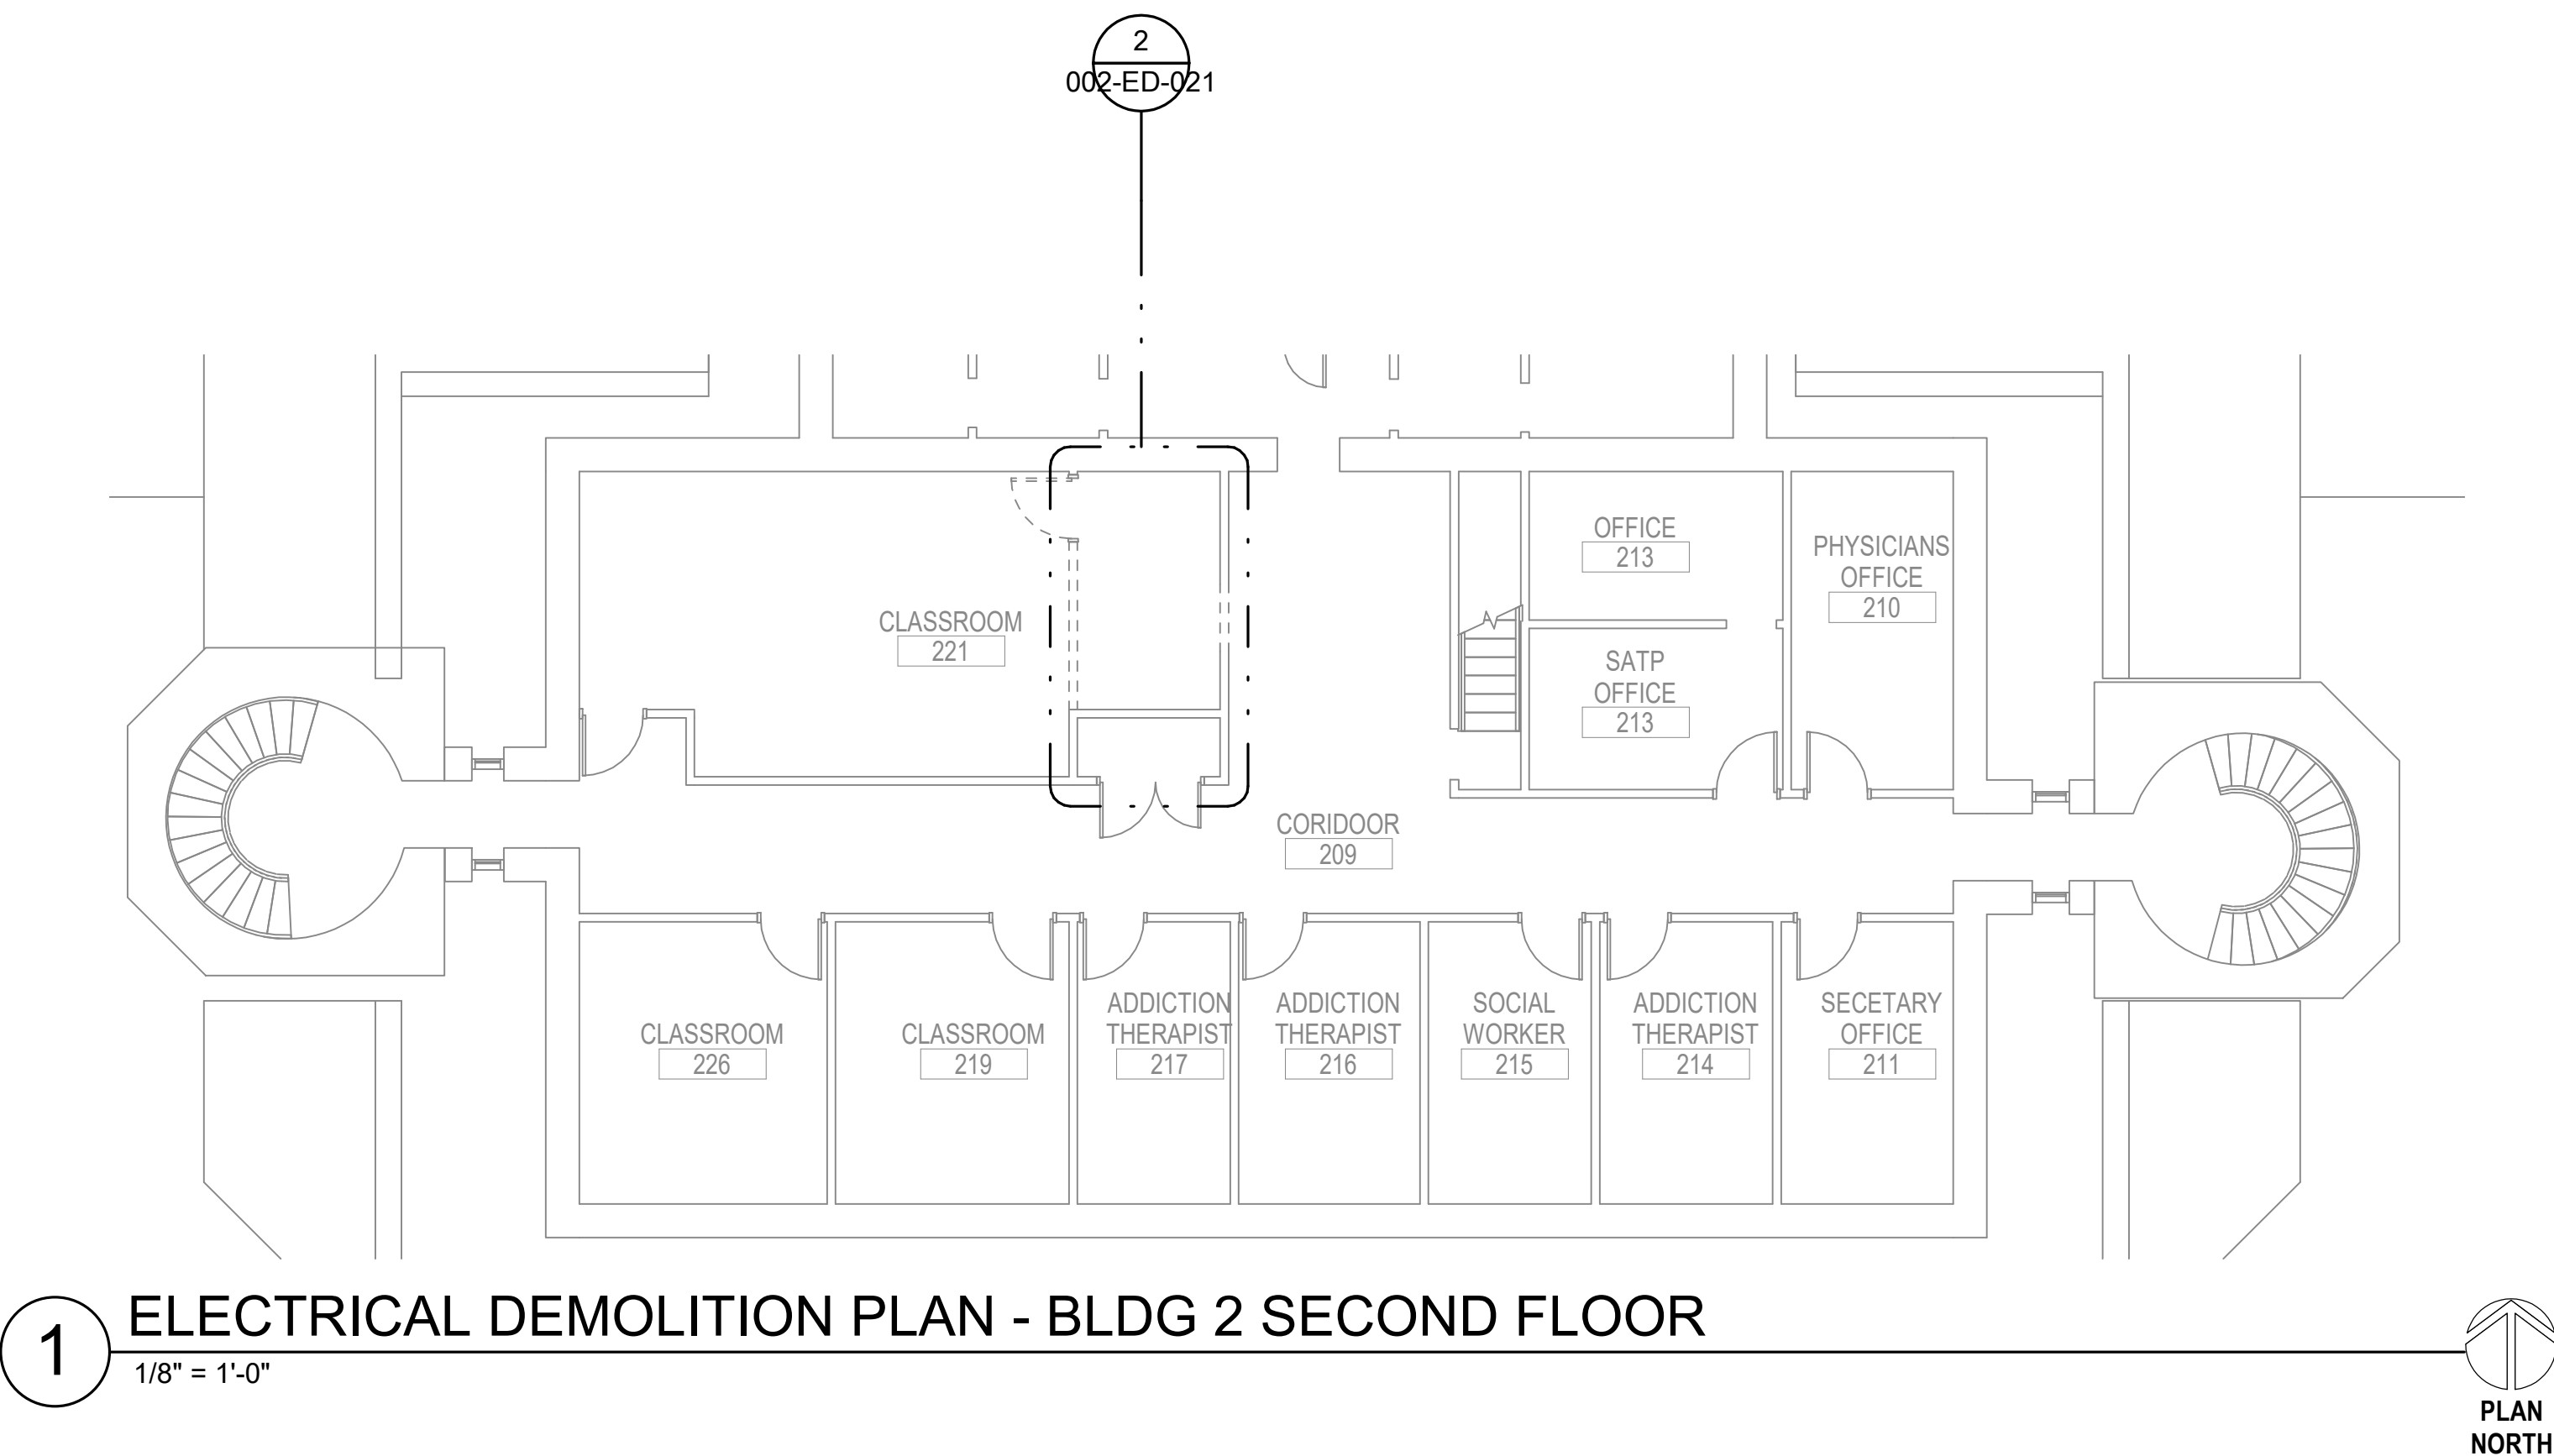


1 ELECTRICAL DEMOLITION PLAN - BLDG 2 SECOND FLOOR
1/8" = 1'-0"

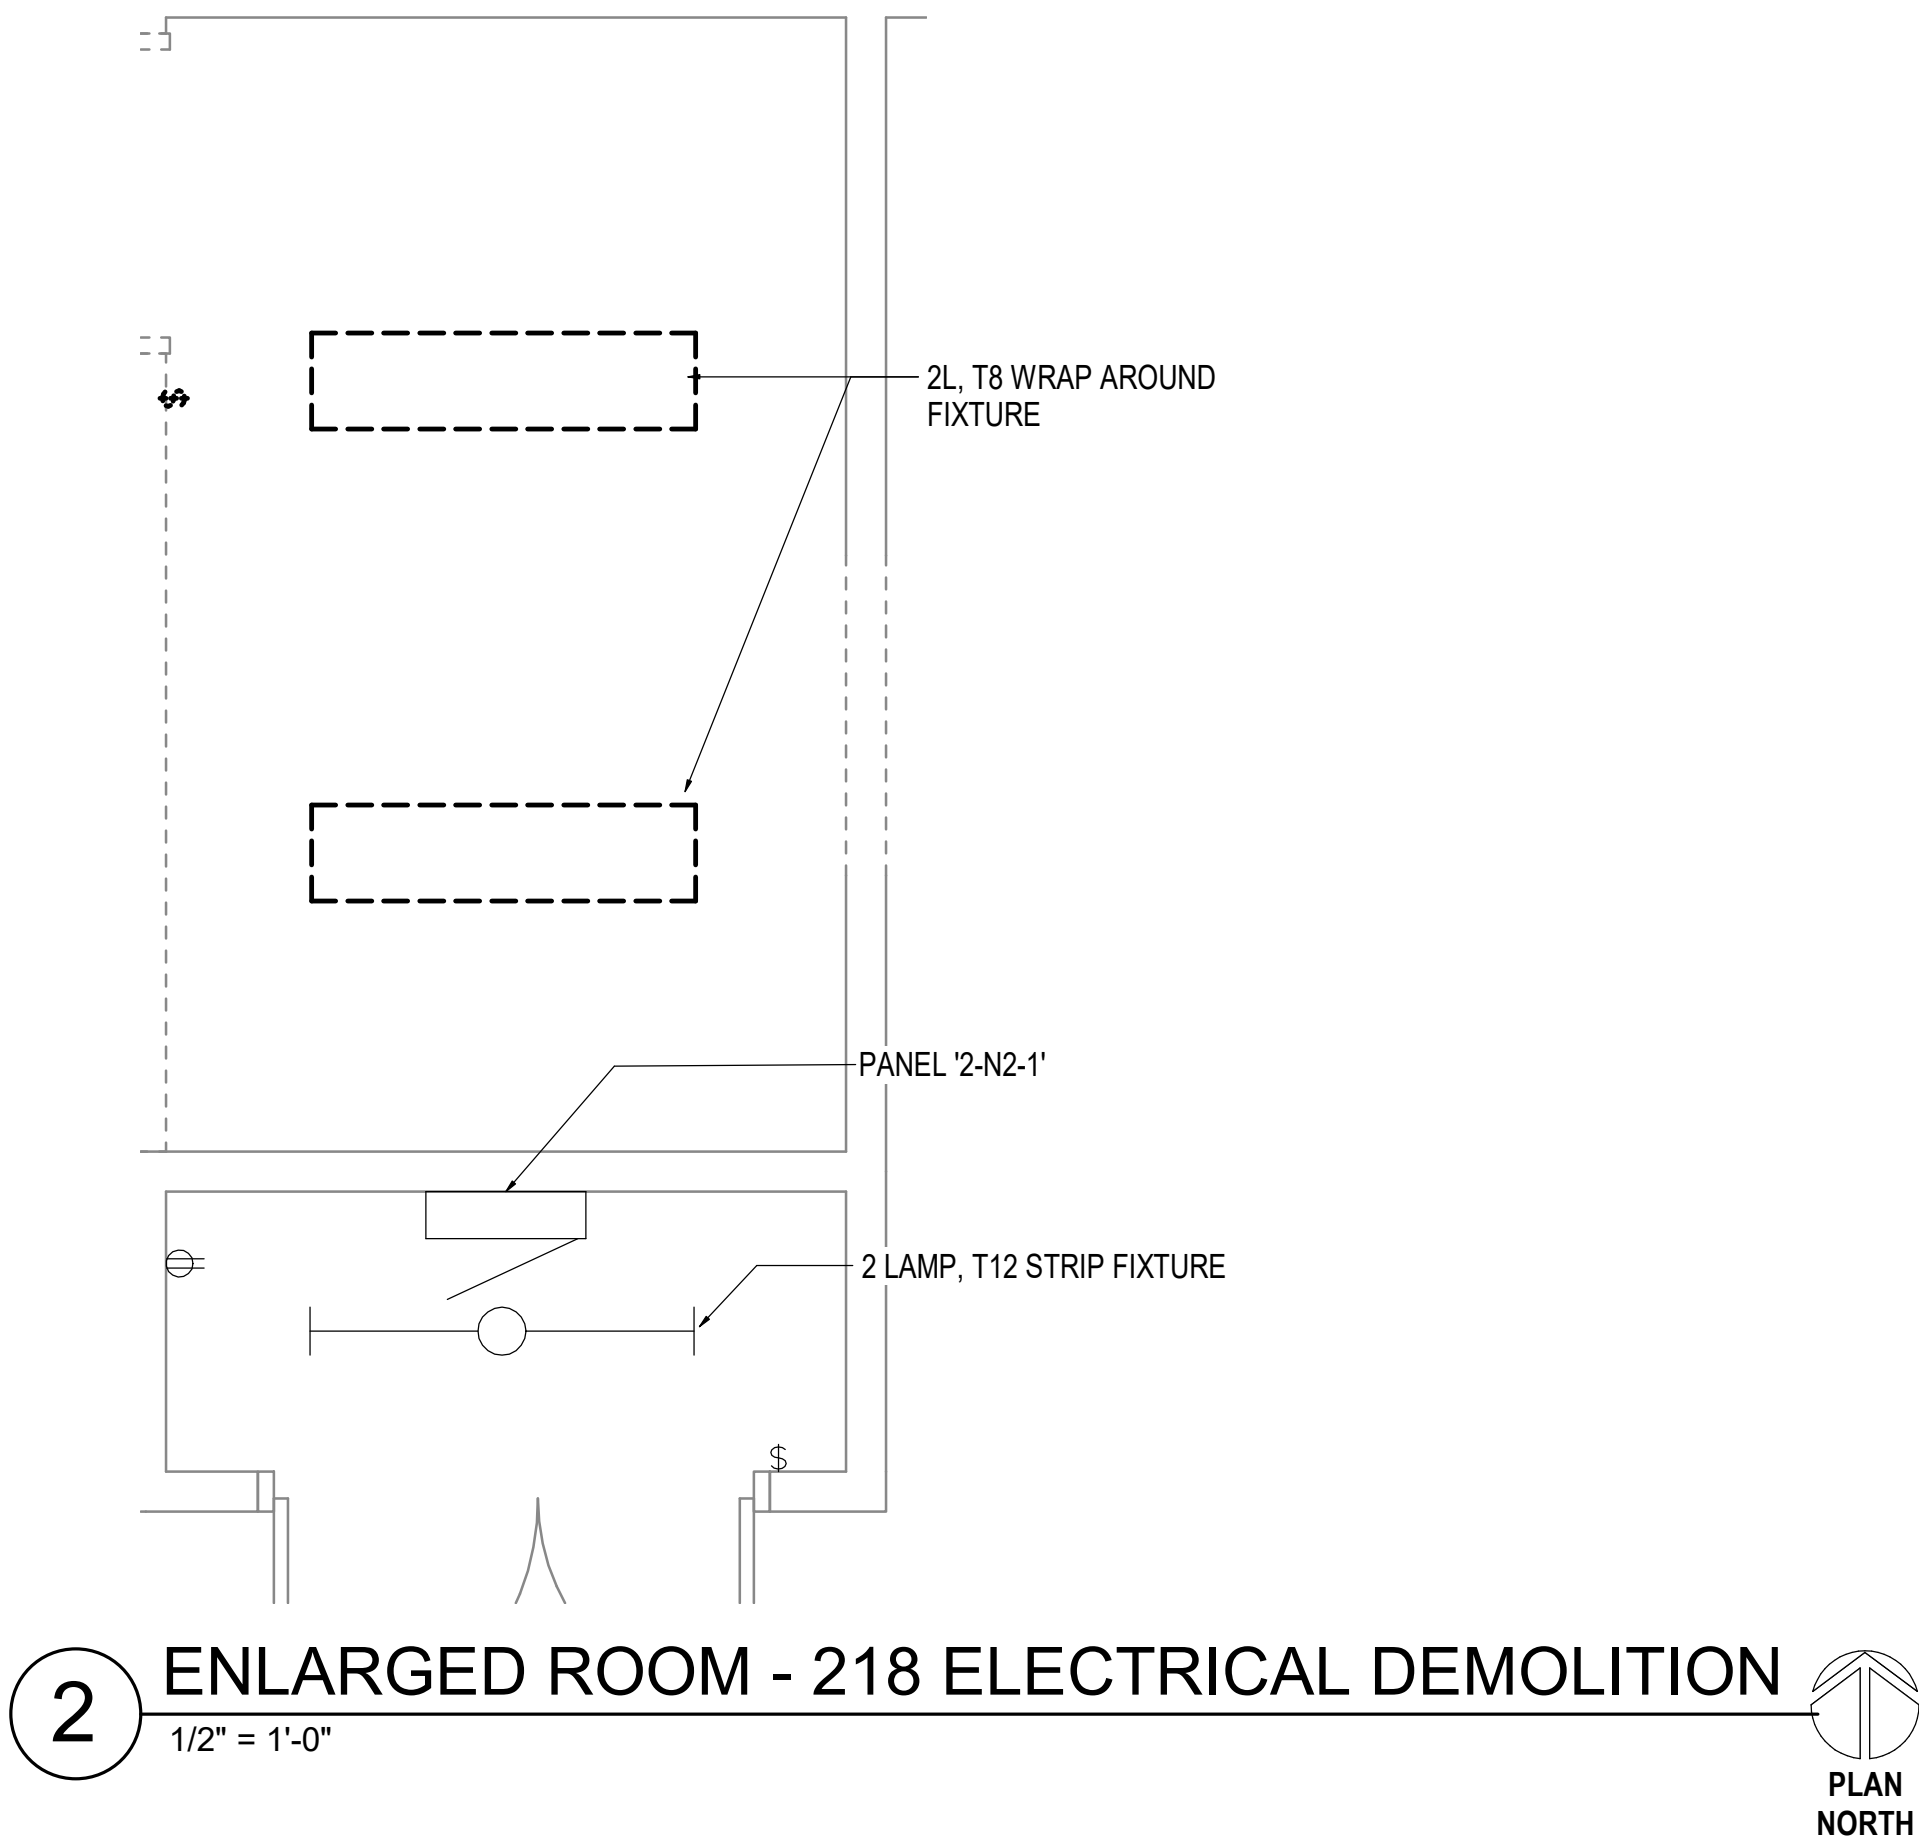

2 ENLARGED ROOM - 218 ELECTRICAL DEMOLITION
1/2" = 1'-0"



SITE LEGEND

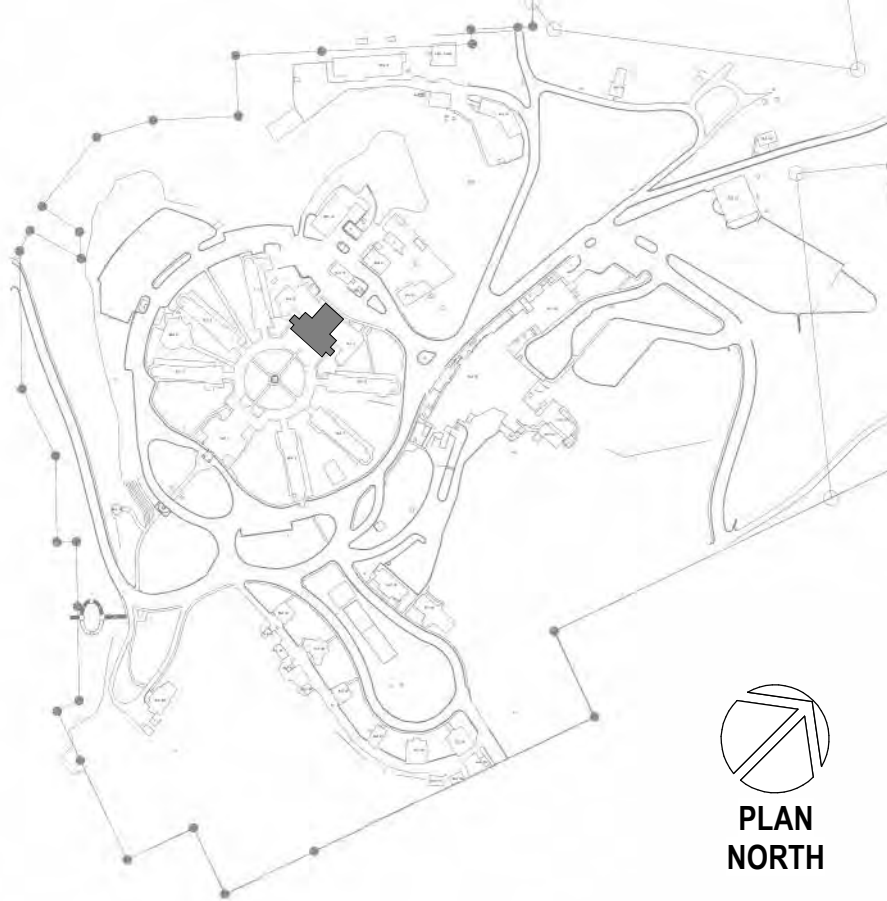

Revisions:	Date:

CONSULTANT

A/E:
GDM
1000 W STEUBEN ST, UNIT 3
BINGEN, WA 98605
541.436.4723
ADAM GOODIN, PE

GDM
ARCHITECTS • ENGINEERS

ARCHITECT/ENGINEER OF RECORD

RSA
Engineering, Inc.
MECHANICAL AND ELECTRICAL CONSULTING ENGINEERS
670 West Firwood Lane, Suite 200
Anchorage, AK 99503
Phone (907) 276-0521
Corporate No.: AEC0542

STAMP

STATE OF ALASKA
JEREMY A. MAXIE
EE-113847
REGISTERED PROFESSIONAL ENGINEER

PROGRAM CONTRACTING ACTIVITY CENTRAL (PCAC)

VA U.S. Department of Veterans Affairs

DRAWING TITLE
ELECTRICAL DEMOLITION PLAN - BLDG 2 SECOND FLOOR

APPROVED: Project Director

PHASE
100% CD FINAL SOLUTION

FLS
FULLY SPRINKLERED

PROJECT TITLE
EHRM INFRASTRUCTURE UPGRADES

LOCATION
HOT SPRINGS, SOUTH DAKOTA

ISSUE DATE
2/22/2022

CHECKED BY
JAM

DRAWN BY
CSZ

PROJECT NUMBER
568A4-21-702

BUILDING NUMBER
02

DRAWING NUMBER
002-ED-021



A. THE INFORMATION SHOWN ON THIS DRAWING IS TAKEN FROM RECORD DRAWINGS AND A NON-DESTRUCTIVE WALK THROUGH OF THE FACILITY. THERE IS NO WARRANTY OR GUARANTEE AS TO THE ACCURACY OF THE INFORMATION SHOWN HERE-IN. THE CONTRACTOR SHALL FIELD VERIFY ALL ITEMS SCHEDULED FOR DEMOLITION PRIOR TO START OF WORK

B. THE OWNER SHALL HAVE FIRST RIGHT OF REFUSAL ON ALL SALVAGEABLE MATERIALS. THE CONTRACTOR SHALL DELIVER SALVAGED MATERIALS TO A WAREHOUSE AS DIRECTED BY THE OWNER. THE CONTRACTOR SHALL DISPOSE OF, OFF SITE, ALL UNWANTED MATERIALS.

C. DASHED OR DOTTED LINES INDICATE ITEMS TO BE REMOVED. SOLID LINES INDICATE EXISTING ITEMS TO REMAIN.

D. LIGHTING AND RECEPTACLES SHALL REMAIN IN EXISTING TELECOM ROOMS. NO DEMOLITION UNLESS OTHERWISE NOTED.

1. DEMOLISH SWITCHES, LIGHTING, AND RECEPTACLES IN ROOM. DEMOLISH CIRCUITS TO UPSTREAM JUNCTION BOX TO ALLOW FOR NEW CIRCUITING.

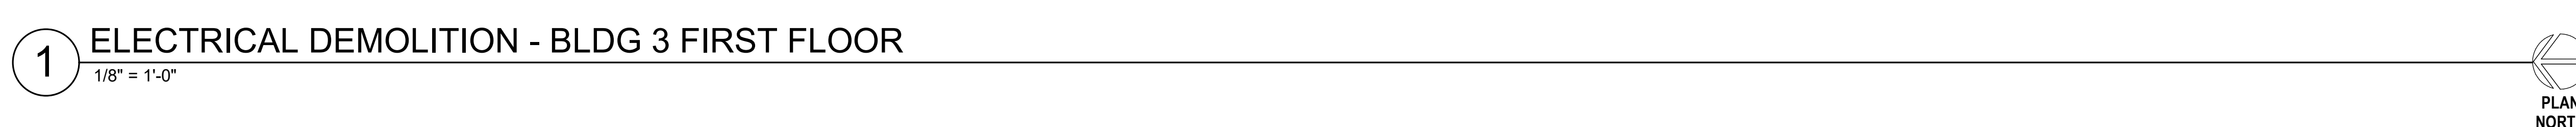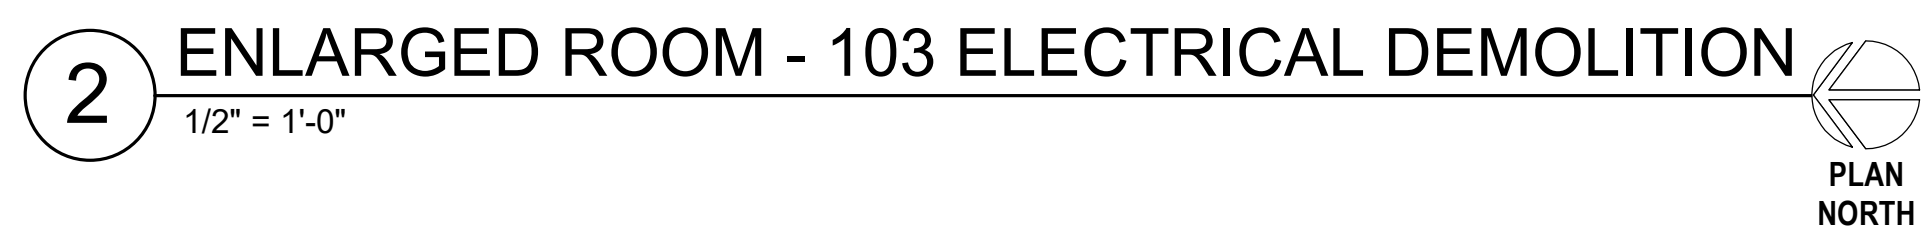[illegible]

CONSULTANT

A/E:
GDM
1000 W STEUBEN ST. UNIT 3
BINGEN, WA 98605
541.436.4723
ADAM GOODIN, PE

ARCHITECT/ENGINEER OF RECORD

R S A

Engineering, Inc.

MECHANICAL AND ELECTRICAL CONSULTING ENGINEERS
670 West Fireweed Lane, Suite 200
Anchorage, AK 99503
Phone (907) 276-8824
Corporate No.: AECCS42

**PROGRAM
CONTRACTING
ACTIVITY
CENTRAL (PCAC)**

VA | U.S. Department
of Veterans Affairs

DRAWING TITLE
ELECTRICAL DEMOLITION PLAN - BLDG 3
APPROVED: Project Director

PHASE	100% CD FINAL SOLUTION
FLS	FULLY SPRINKLERED

PROJECT TITLE			
EHRM INFRASTRUCTURE UPGRADES			
LOCATION			
HOT SPRINGS, SOUTH DAKOTA			
ISSUE DATE		CHECKED BY	
2/22/2022		JAM CSZ	

PROJECT NUMBER
568A4-21-702
BUILDING NUMBER
03
DRAWING NUMBER
003-ED-0B1

A


B

C


D

E


F

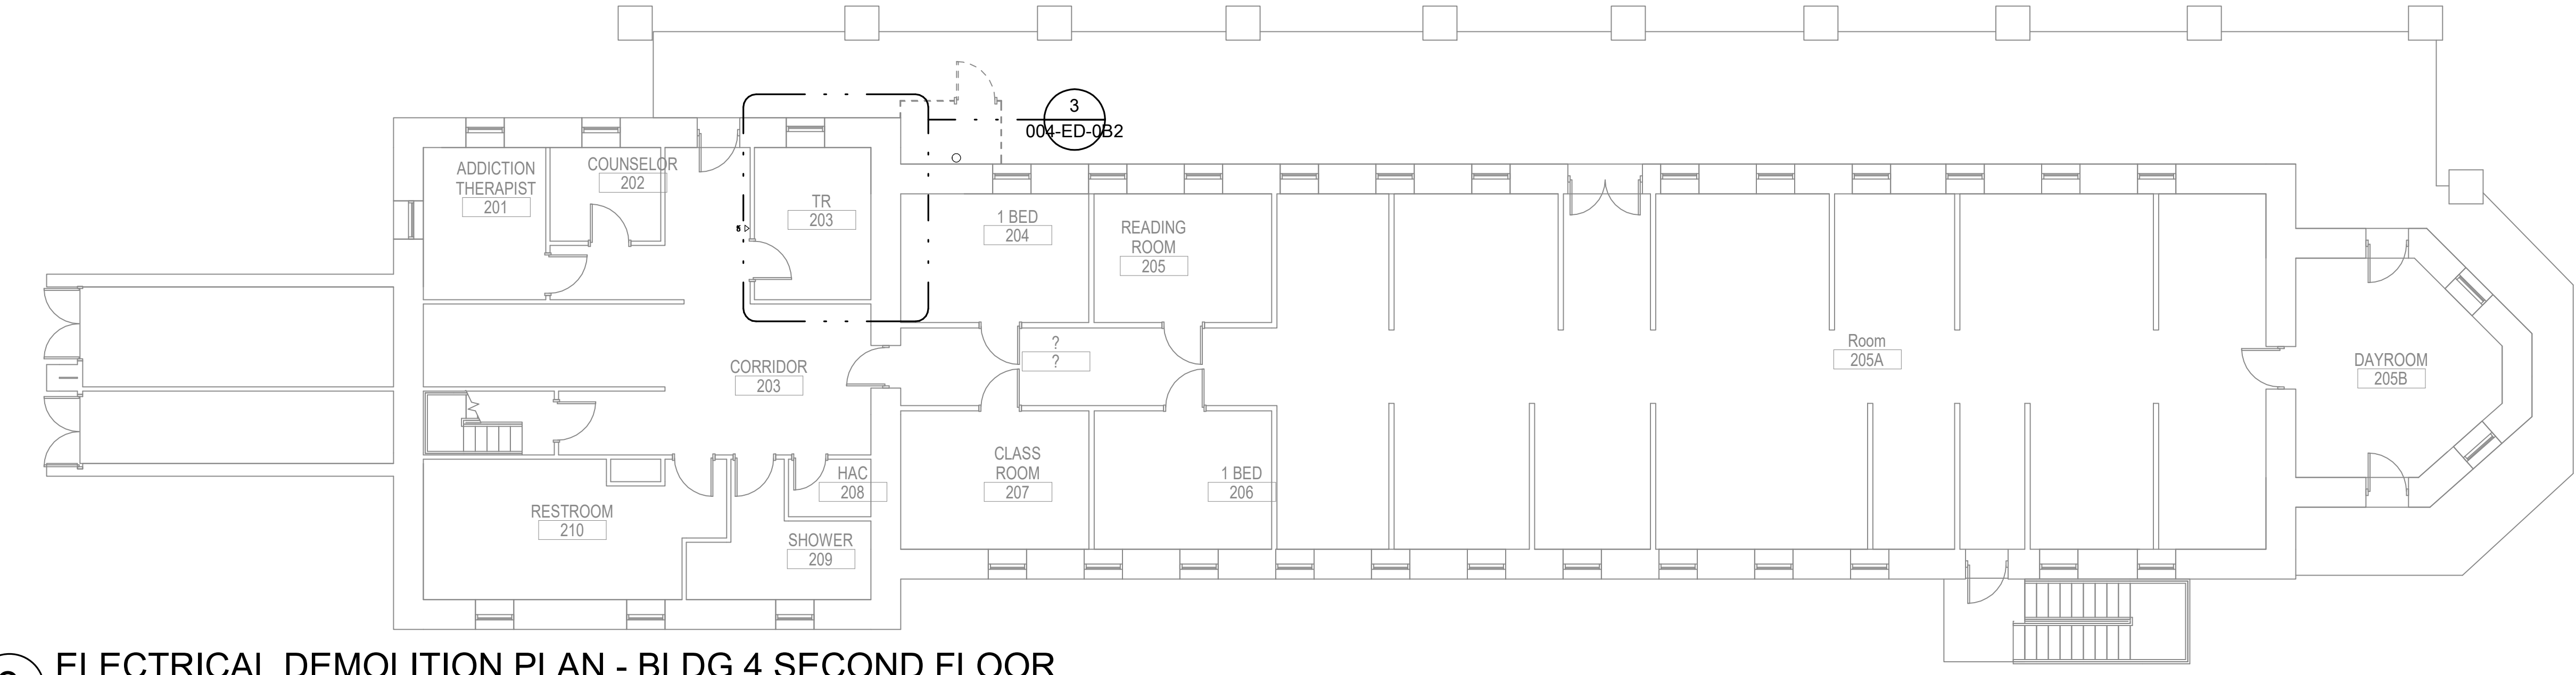

3 ELECTRICAL DEMOLITION PLAN - BLDG 4 SECOND FLOOR
1/8" = 1'-0"

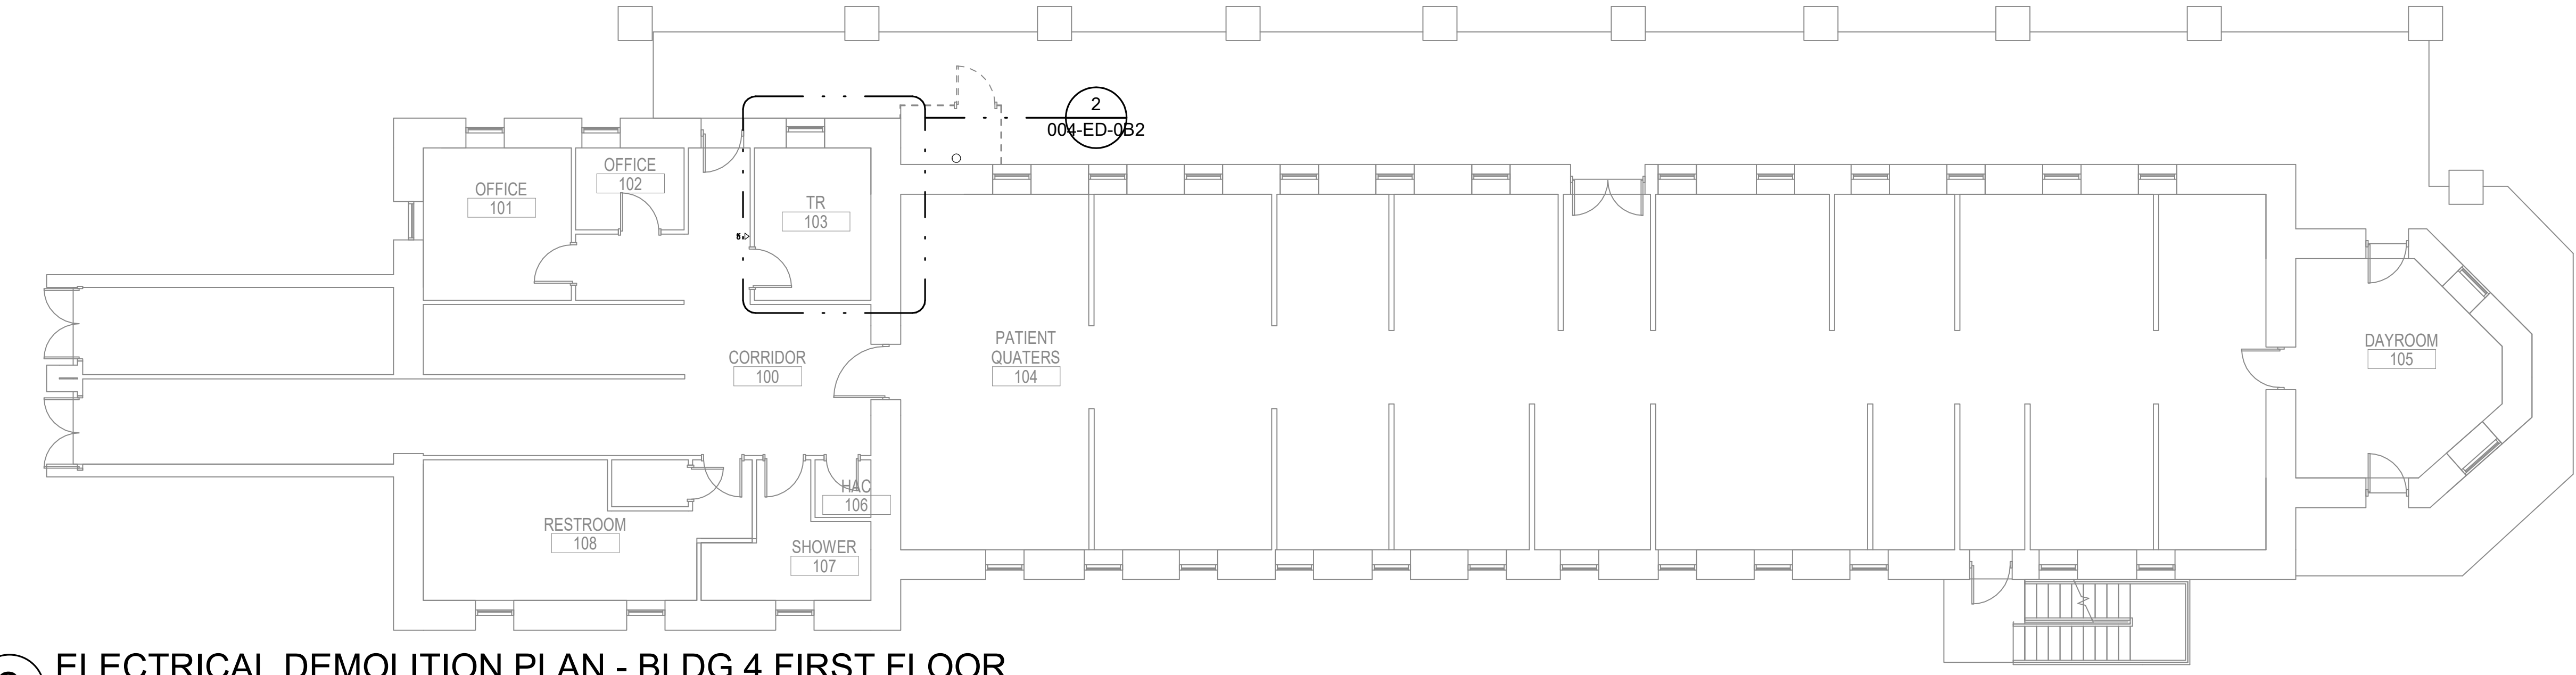

2 ELECTRICAL DEMOLITION PLAN - BLDG 4 FIRST FLOOR
1/8" = 1'-0"

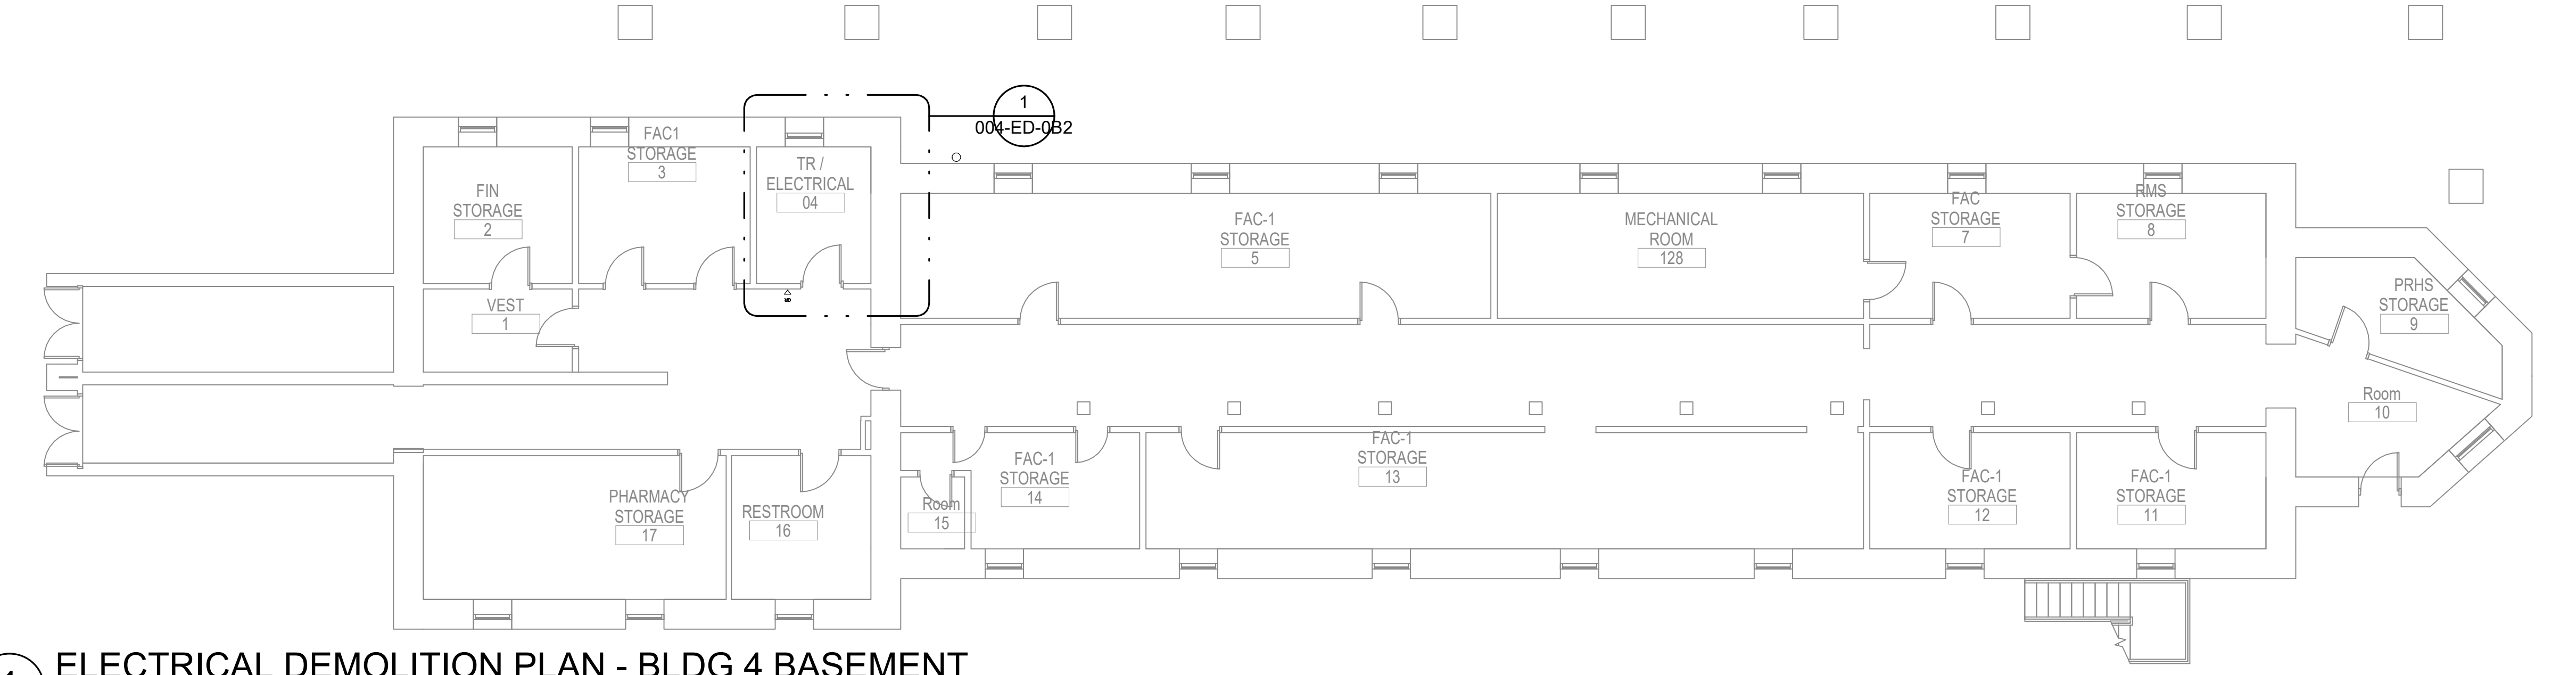


1 ELECTRICAL DEMOLITION PLAN - BLDG 4 BASEMENT
1/8" = 1'-0"



GENERAL NOTES:

- A. THE INFORMATION SHOWN ON THIS DRAWING IS TAKEN FROM RECORD DRAWINGS AND A NON-DESTRUCTIVE WALK THROUGH OF THE FACILITY. THERE IS NO WARRANTY OR GUARANTEE AS TO THE ACCURACY OF THE INFORMATION SHOWN HERE-IN. THE CONTRACTOR SHALL FIELD VERIFY ALL ITEMS SCHEDULED FOR DEMOLITION PRIOR TO START OF WORK.
- B. THE OWNER SHALL HAVE FIRST RIGHT OF REFUSAL ON ALL SALVAGEABLE MATERIALS. THE CONTRACTOR SHALL DELIVER SALVAGED MATERIALS TO A WAREHOUSE AS DIRECTED BY THE OWNER. THE CONTRACTOR SHALL DISPOSE OF, OFF SITE, ALL UNWANTED MATERIALS.
- C. DASHED OR DOTTED LINES INDICATE ITEMS TO BE REMOVED. SOLID LINES INDICATE EXISTING ITEMS TO REMAIN.
- D. LIGHTING AND RECEPTACLES SHALL REMAIN IN EXISTING TELECOM ROOMS. NO DEMOLITION UNLESS OTHERWISE NOTED.

SITE LEGEND

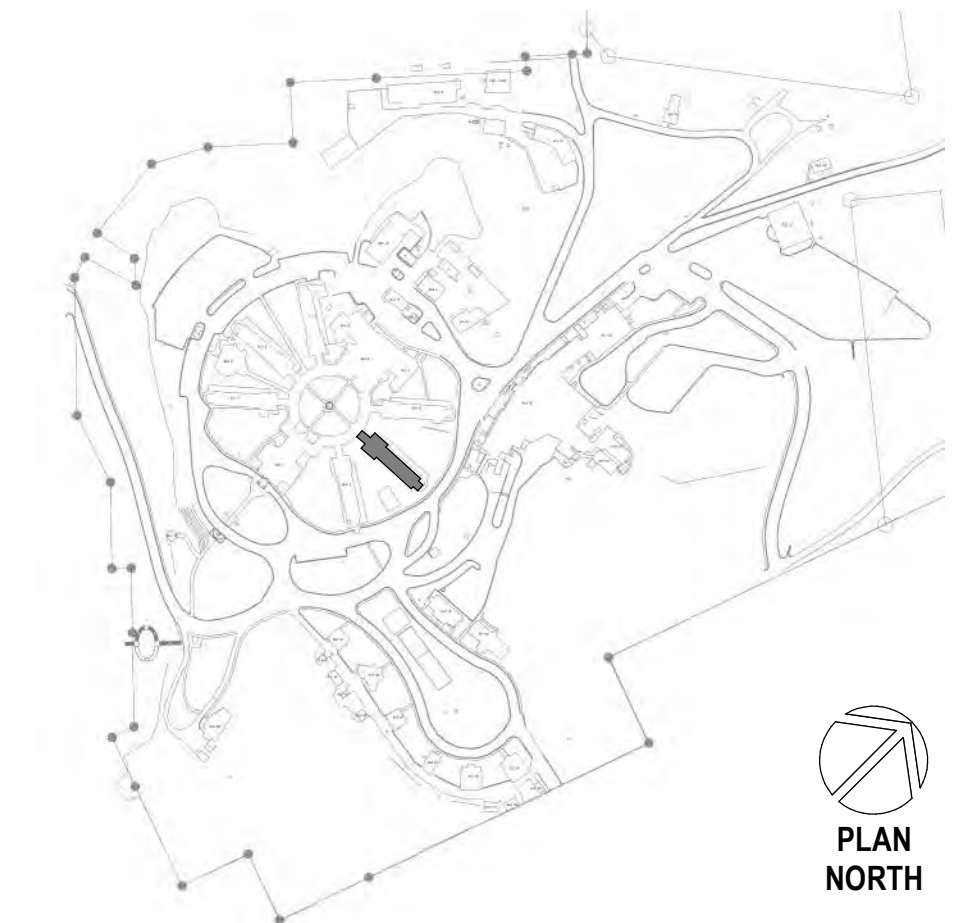

Revisions:	Date:

CONSULTANT

A/E:
GDM
1000 W STEUBEN ST. UNIT 3
BINGEN, WA 98605
541.436.4723
ADAM GOODIN, PE

ARCHITECT/ENGINEER OF RECORD

RSA
Engineering, Inc.
MECHANICAL AND ELECTRICAL CONSULTING ENGINEERS
670 West Fireweed Lane, Suite 200
Anchorage, AK 99503
Phone (907) 278-0521
Corporate No.: AEC0542

STAMP

PROGRAM CONTRACTING ACTIVITY CENTRAL (PCAC)

VA U.S. Department of Veterans Affairs

DRAWING TITLE
ELECTRICAL DEMO PLAN - BLDG 4 LAYOUTS

APPROVED: Project Director

PHASE
100% CD FINAL SOLUTION

FLS
FULLY SPRINKLERED

PROJECT TITLE
EHRM INFRASTRUCTURE UPGRADES

LOCATION
HOT SPRINGS, SOUTH DAKOTA

ISSUE DATE
2/22/2022

CHECKED BY
JAM

DRAWN BY
NVF

PROJECT NUMBER
568A4-21-702

BUILDING NUMBER
04

DRAWING NUMBER
004-ED-0B1

A

B

C

D

E

F

A

B

C


D

E


F

GENERAL NOTES:


- A. THE INFORMATION SHOWN ON THIS DRAWING IS TAKEN FROM RECORD DRAWINGS AND A NON-DESTRUCTIVE WALK THROUGH OF THE FACILITY. THERE IS NO WARRANTY OR GUARANTEE AS TO THE ACCURACY OF THE INFORMATION SHOWN HERE-IN. THE CONTRACTOR SHALL FIELD VERIFY ALL ITEMS SCHEDULED FOR DEMOLITION PRIOR TO START OF WORK.
- B. THE OWNER SHALL HAVE FIRST RIGHT OF REFUSAL ON ALL SALVAGEABLE MATERIALS. THE CONTRACTOR SHALL DELIVER SALVAGED MATERIALS TO A WAREHOUSE AS DIRECTED BY THE OWNER. THE CONTRACTOR SHALL DISPOSE OF, OFF SITE, ALL UNWANTED MATERIALS.
- C. DASHED OR DOTTED LINES INDICATE ITEMS TO BE REMOVED. SOLID LINES INDICATE EXISTING ITEMS TO REMAIN.
- D. LIGHTING AND RECEPTACLES SHALL REMAIN IN EXISTING TELECOM ROOMS. NO DEMOLITION UNLESS OTHERWISE NOTED.

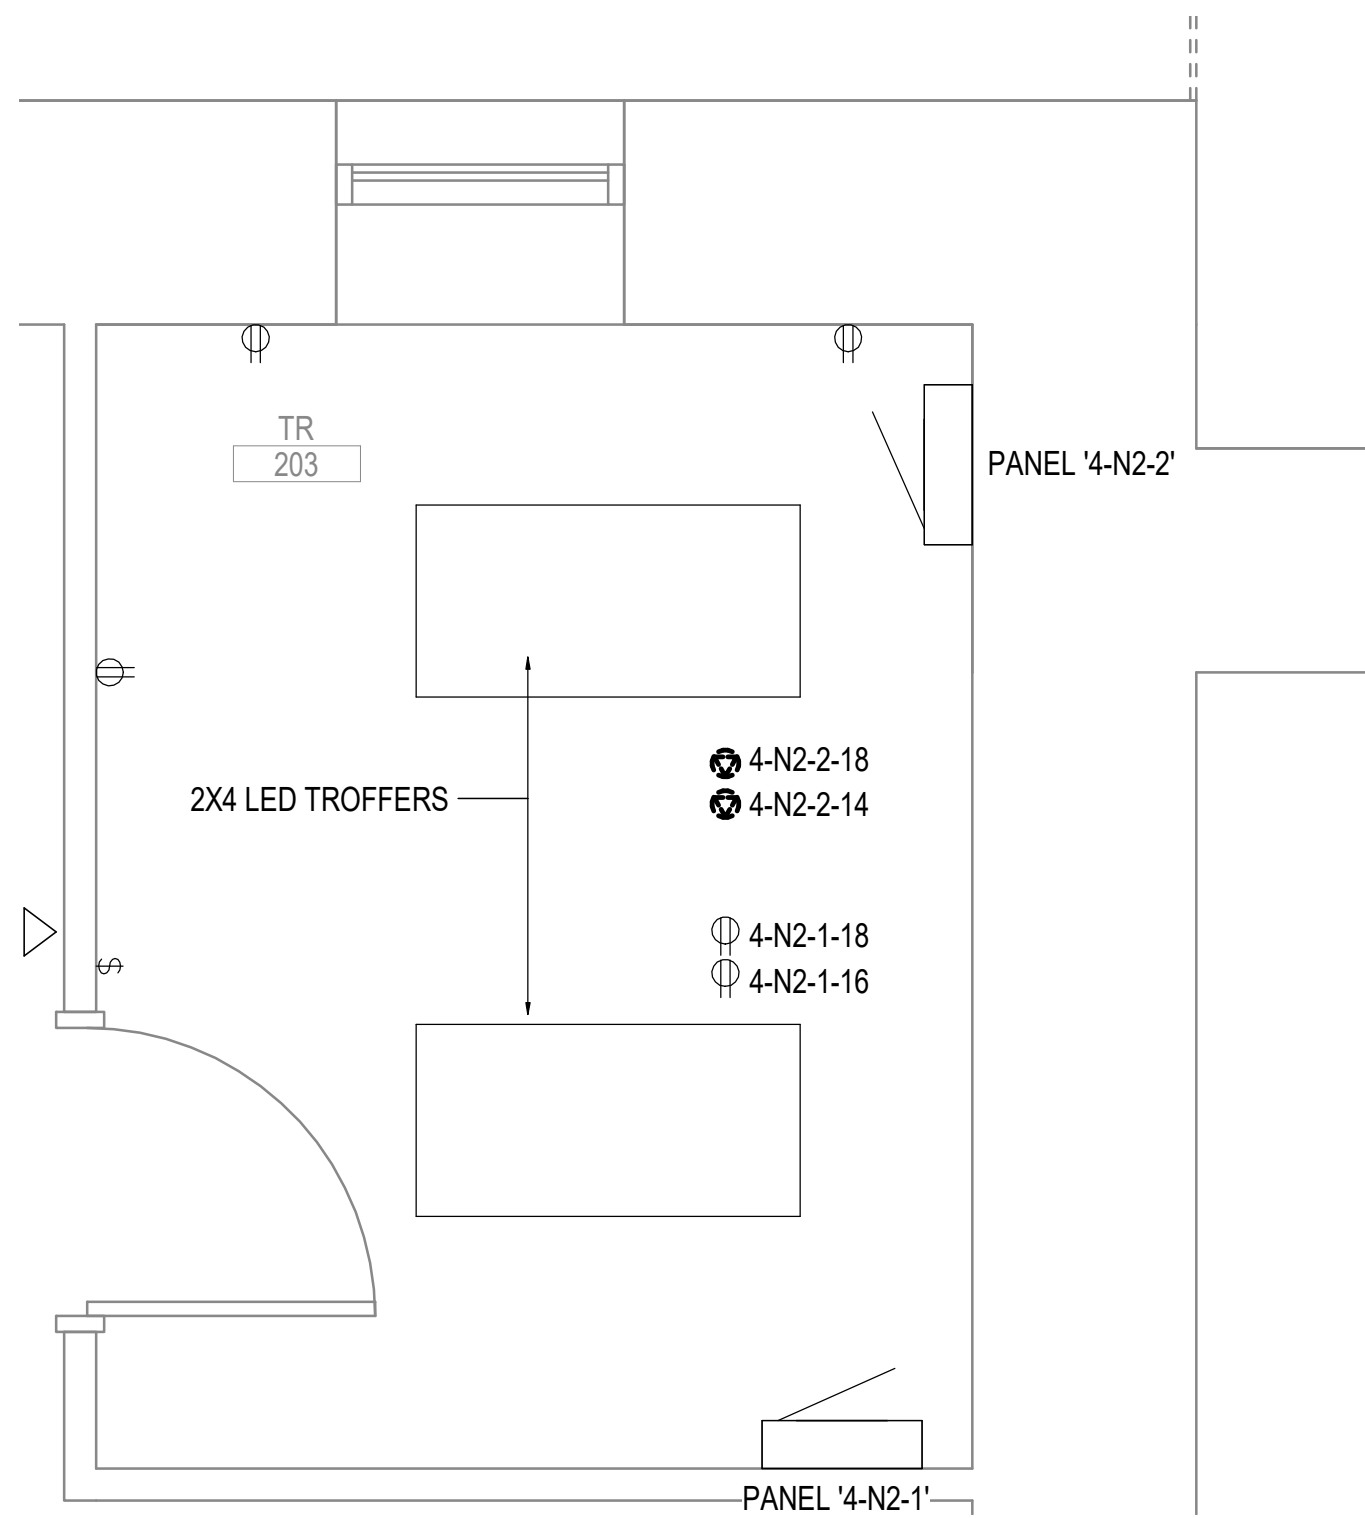

3 ENLARGED ROOM - 203 ELECTRICAL DEMOLITION
1/2" = 1'-0"

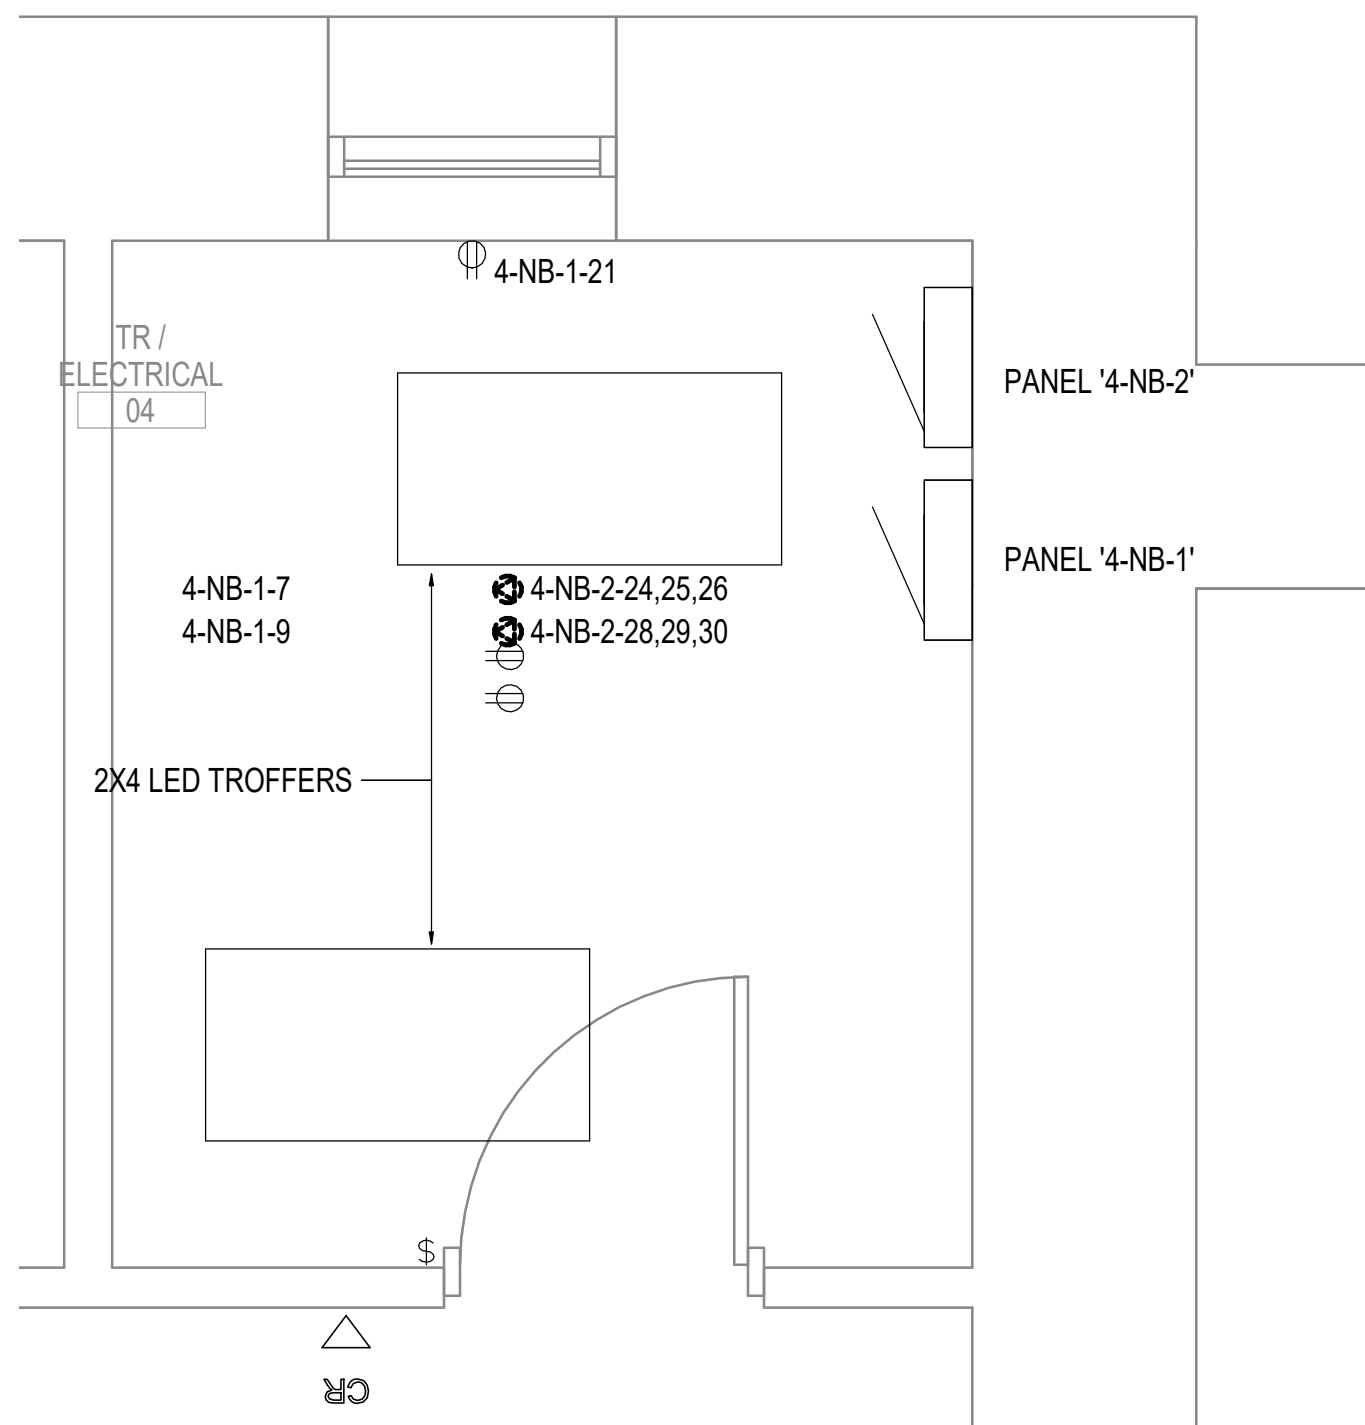


1 ENLARGED ROOM - 04 ELECTRICAL DEMOLITION
1/2" = 1'-0"

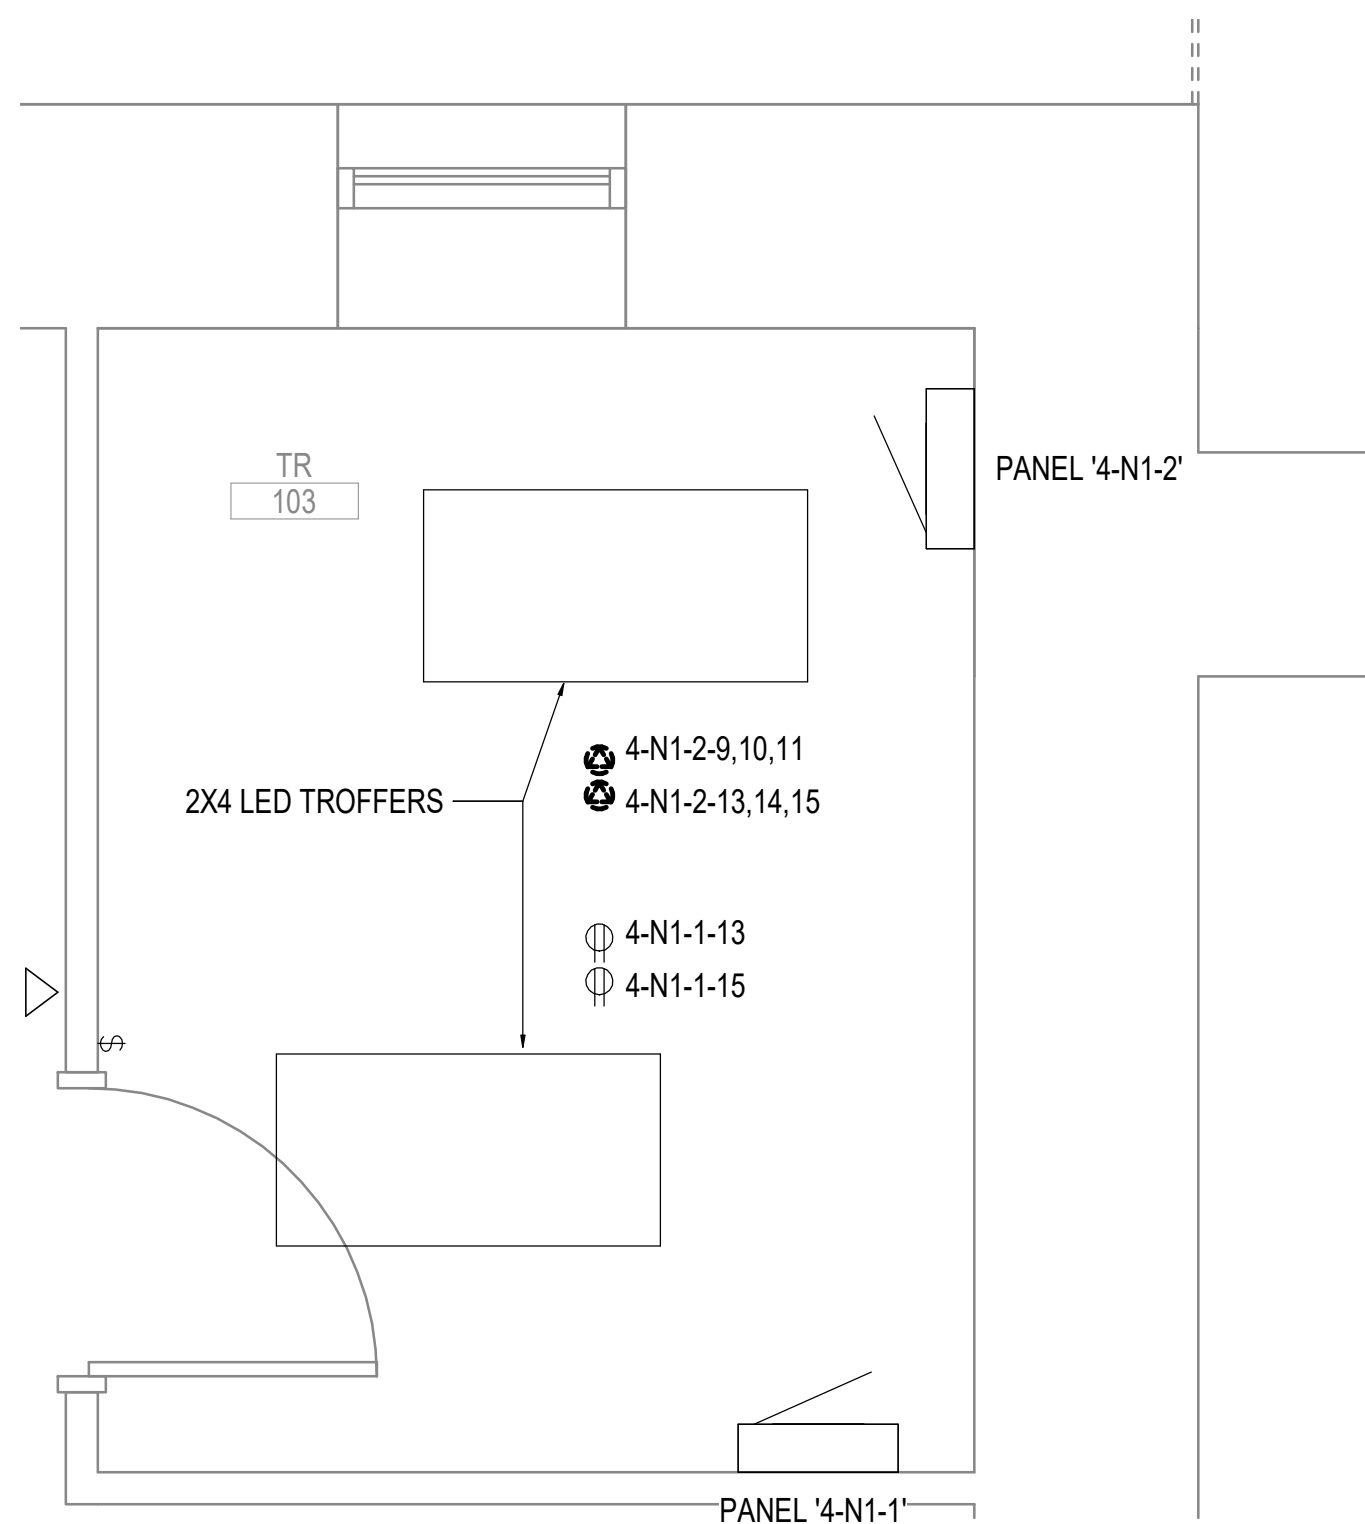

2 ENLARGED ROOM - 103 ELECTRICAL DEMOLITION
1/2" = 1'-0"



SITE LEGEND

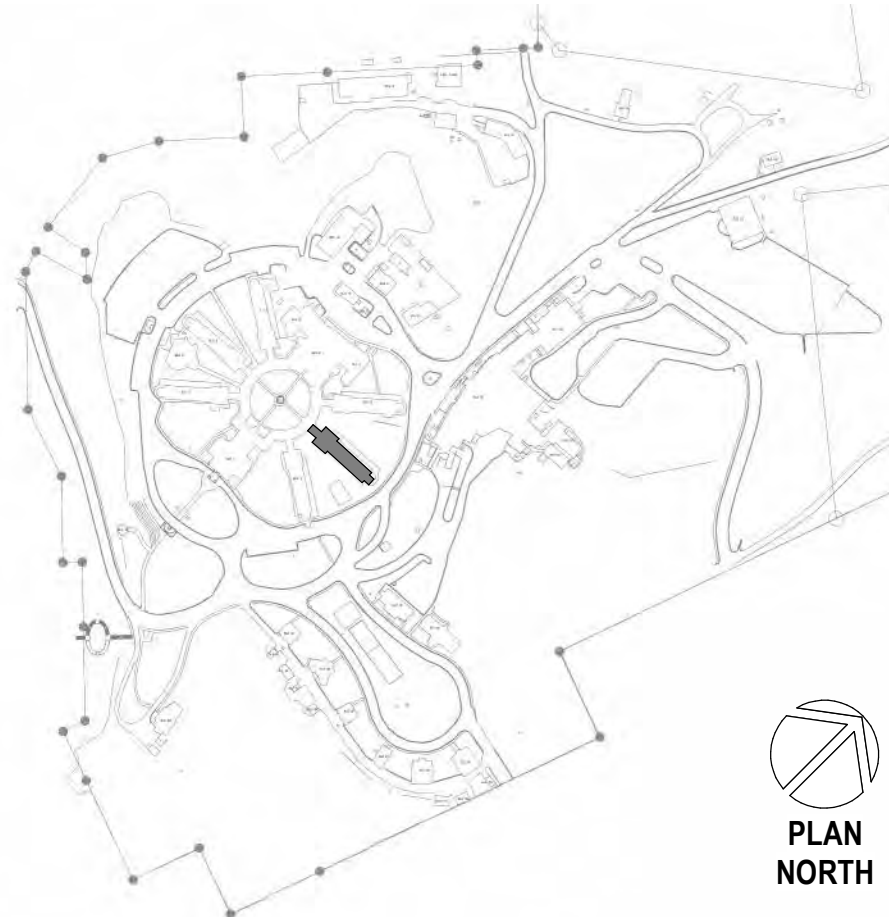

C:\Users\Caleb\AppData\Local\Microsoft\Windows\Temporary Internet Files\Content.IE5\B3QJ6T6M\1x1 2/22/2022 8:02:57 PM

Revisions:	Date:

CONSULTANT

A/E:
GDM
1000 W STEUBEN ST. UNIT 3
BINGEN, WA 98605
541.436.4723
ADAM GOODIN, PE

GDM
ARCHITECTS • ENGINEERS

ARCHITECT/ENGINEER OF RECORD

RSA
Engineering, Inc.
MECHANICAL AND ELECTRICAL CONSULTING ENGINEERS
670 West Firwood Lane, Suite 200
Anchorage, AK 99503
Phone (907) 276-0521
Corporate No.: AECC542

STAMP

STATE OF ALASKA
JEREMY A. MAKIE
EE-113942
REGISTERED PROFESSIONAL ENGINEER

PROGRAM CONTRACTING ACTIVITY CENTRAL (PCAC)

VA U.S. Department of Veterans Affairs

DRAWING TITLE
ELECTRICAL DEMOLITION PLAN - BLDG 4 ENLARGED PLANS

APPROVED: Project Director

PHASE
100% CD FINAL SOLUTION

FLS
FULLY SPRINKLERED

PROJECT TITLE
EHRM INFRASTRUCTURE UPGRADES

LOCATION
HOT SPRINGS, SOUTH DAKOTA

ISSUE DATE
2/22/2022

CHECKED BY
JAM

DRAWN BY
NVF

PROJECT NUMBER
568A4-21-702

BUILDING NUMBER
04


DRAWING NUMBER
004-ED-0B2

GENERAL NOTES:

- A. THE INFORMATION SHOWN ON THIS DRAWING IS TAKEN FROM RECORD DRAWINGS AND A NON-DESTRUCTIVE WALK THROUGH OF THE FACILITY. THERE IS NO WARRANTY OR GUARANTEE AS TO THE ACCURACY OF THE INFORMATION SHOWN HERE-IN. THE CONTRACTOR SHALL FIELD VERIFY ALL ITEMS SCHEDULED FOR DEMOLITION PRIOR TO START OF WORK.
- B. THE OWNER SHALL HAVE FIRST RIGHT OF REFUSAL ON ALL SALVAGEABLE MATERIALS. THE CONTRACTOR SHALL DELIVER SALVAGED MATERIALS TO A WAREHOUSE AS DIRECTED BY THE OWNER. THE CONTRACTOR SHALL DISPOSE OF, OFF SITE, ALL UNWANTED MATERIALS.
- C. DASHED OR DOTTED LINES INDICATE ITEMS TO BE REMOVED. SOLID LINES INDICATE EXISTING ITEMS TO REMAIN.
- D. LIGHTING AND RECEPTACLES SHALL REMAIN IN EXISTING TELECOM ROOMS. NO DEMOLITION UNLESS OTHERWISE NOTED.


SHEET NOTES:

1. DEMOLISH SWITCHES, LIGHTING, AND RECEPTACLES IN ROOM. DEMOLISH CIRCUITS TO UPSTREAM JUNCTION BOX TO ALLOW FOR NEW CIRCUITING.

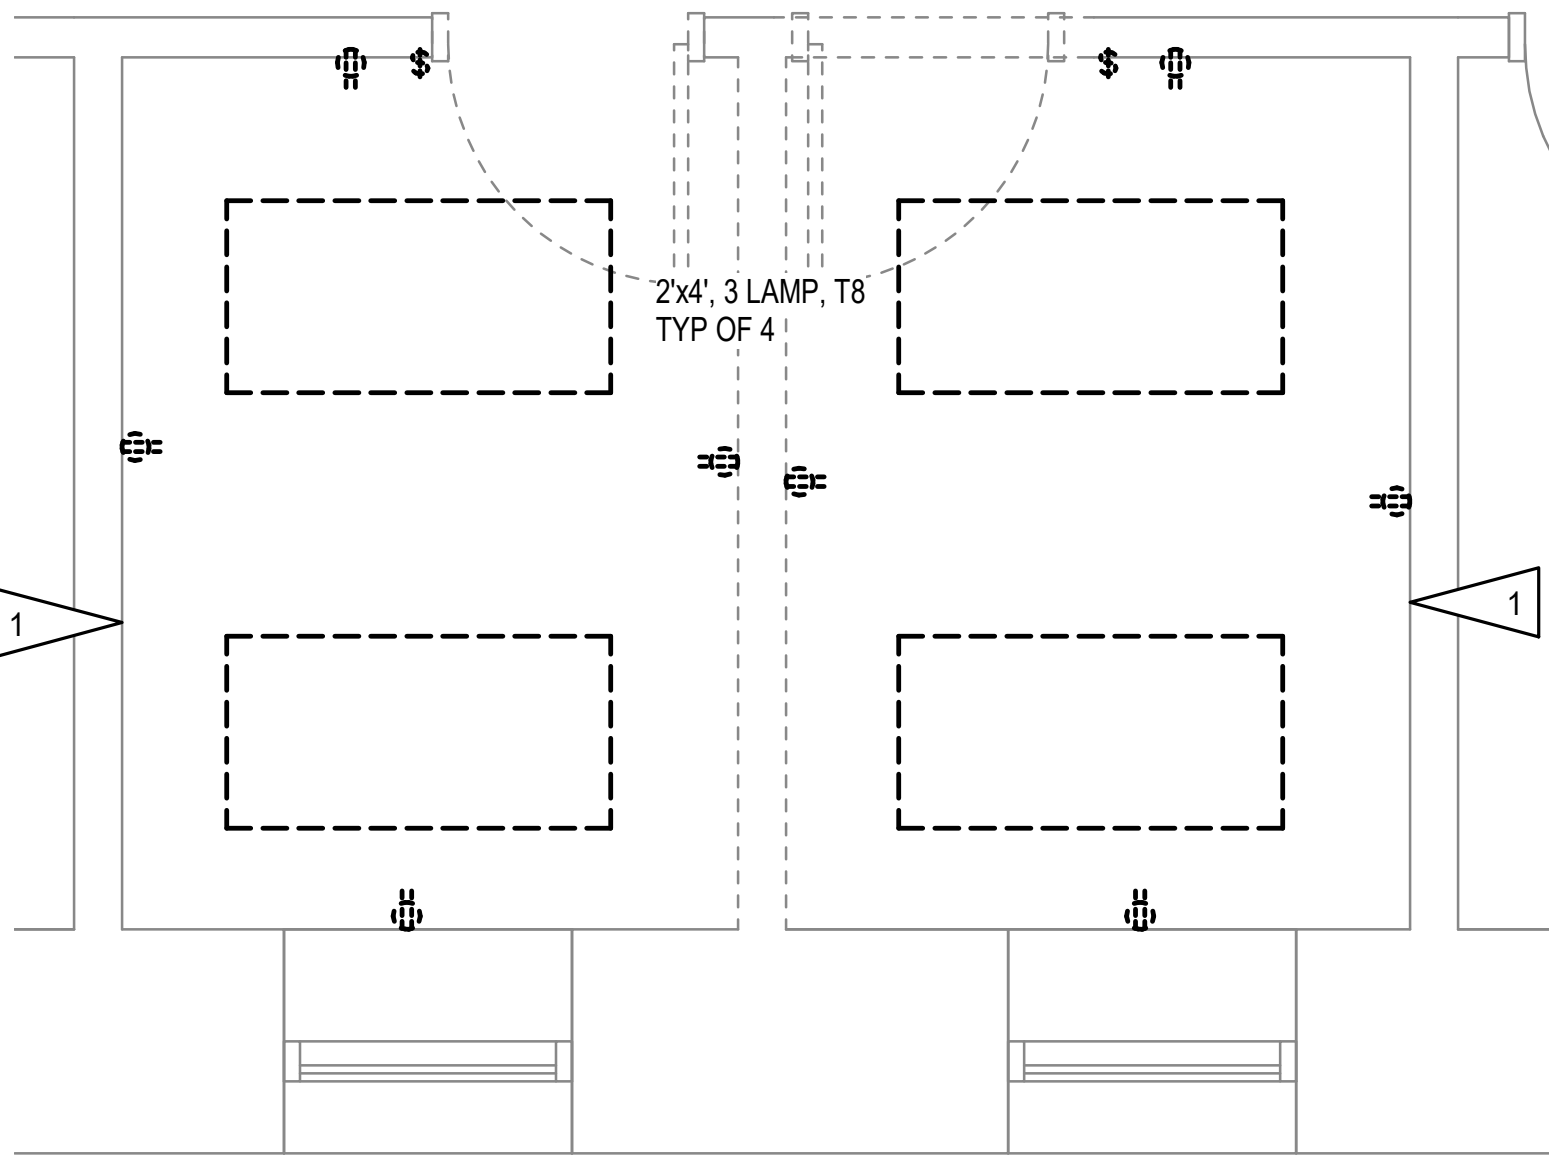

2 ENLARGED ROOM - 211 ELECTRICAL DEMOLITION

1/2" = 1'-0"

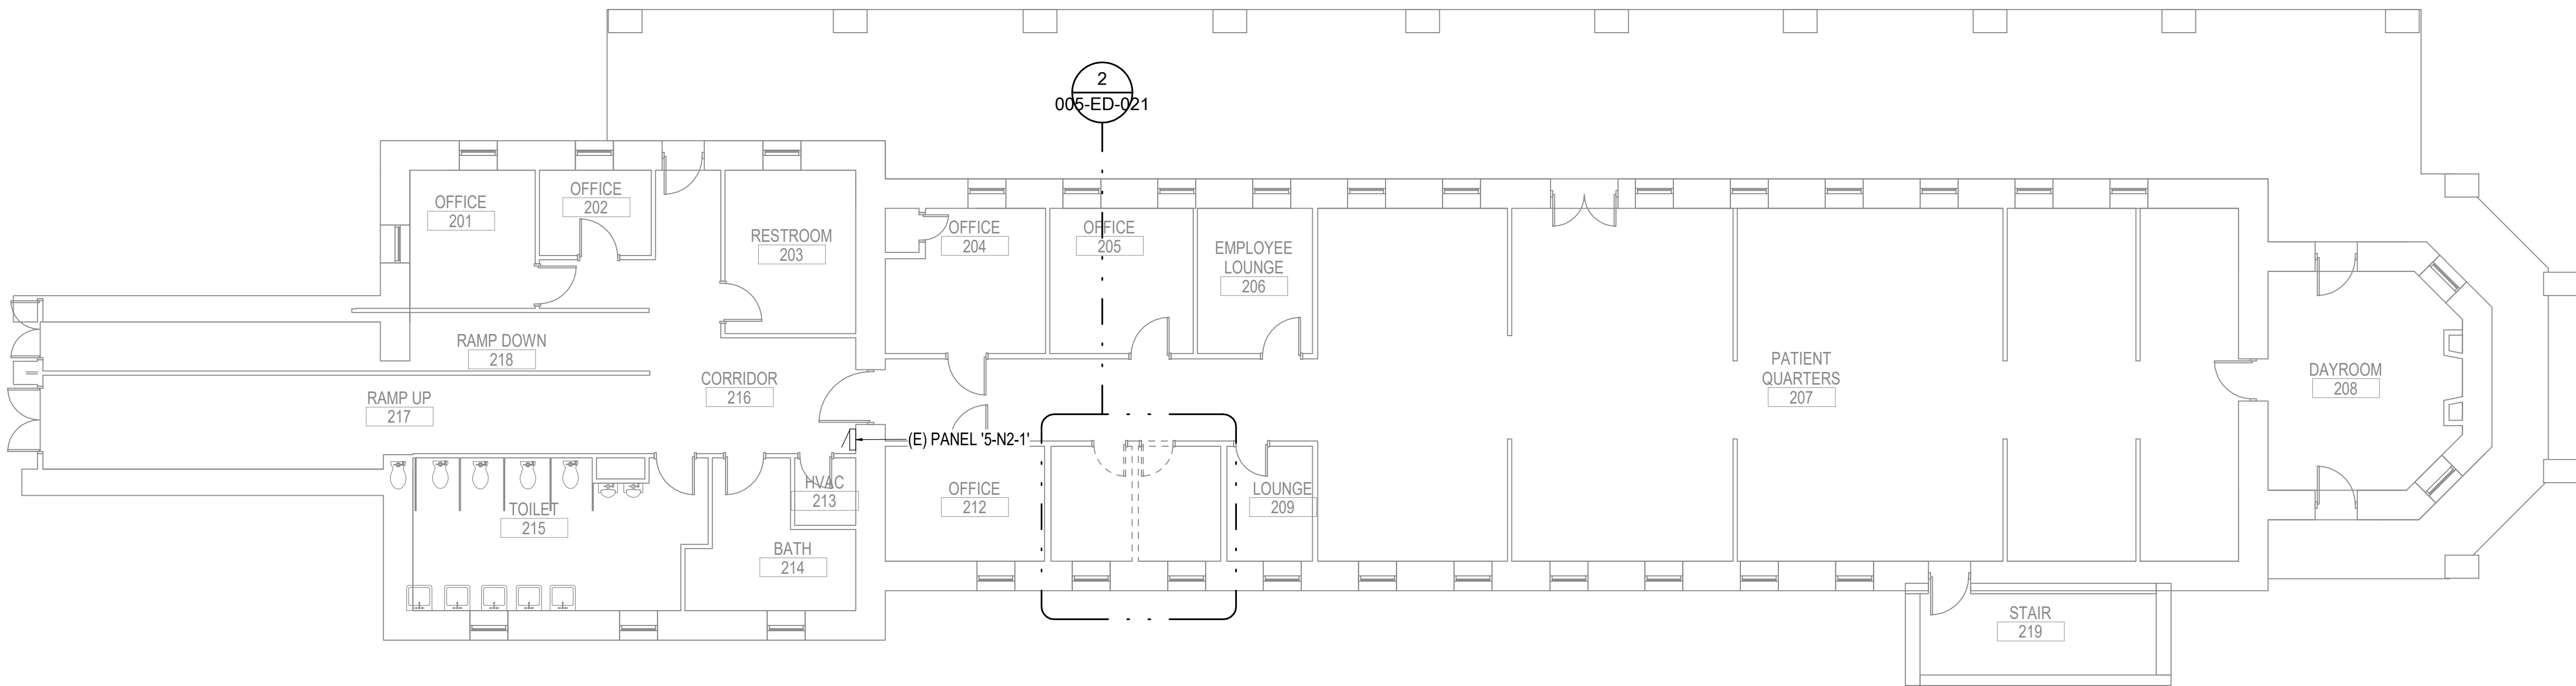


1 ELECTRICAL DEMOLITION PLAN - BLDG 5 SECOND FLOOR

1/8" = 1'-0"



SITE LEGEND

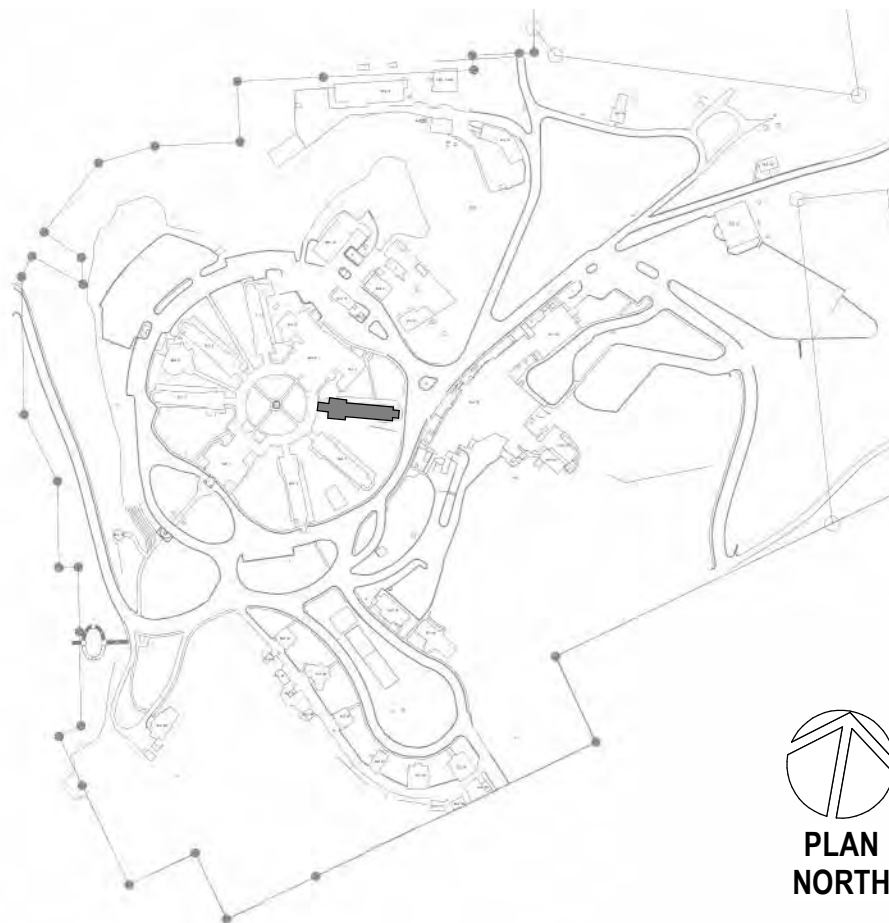

Revisions:	Date:

CONSULTANT

A/E:
GDM
1000 W STEUBEN ST. UNIT 3
BINGEN, WA 98605
541.436.4723
ADAM GOODIN, PE

GDM
ARCHITECTS • ENGINEERS

ARCHITECT/ENGINEER OF RECORD

RSA
Engineering, Inc.
MECHANICAL AND ELECTRICAL CONSULTING ENGINEERS
670 West Firwood Lane, Suite 200
Anchorage, AK 99503
Phone (907) 278-0521
Corporate No.: AEC0542

STAMP

STATE OF ALASKA
4010
JEREMY A. MAXIE
REGISTERED PROFESSIONAL ENGINEER
No. 111847
EXPIRATION DATE 12/31/2024

PROGRAM CONTRACTING ACTIVITY CENTRAL (PCAC)

VA U.S. Department of Veterans Affairs

DRAWING TITLE
ELECTRICAL DEMOLITION PLAN - BLDG 5 SECOND FLOOR

APPROVED: Project Director

PHASE
100% CD FINAL SOLUTION

FLS
FULLY SPRINKLERED

PROJECT TITLE
EHRM INFRASTRUCTURE UPGRADES

LOCATION
HOT SPRINGS, SOUTH DAKOTA

ISSUE DATE
02/22/2022


CHECKED BY
JAM

DRAWN BY
CSZ


PROJECT NUMBER
568A4-21-702

BUILDING NUMBER
05


DRAWING NUMBER
005-ED-021

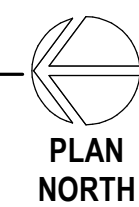

PLAN
NORTH

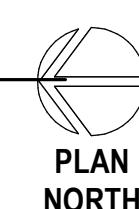

PLAN
NORTH

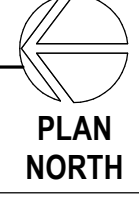

PLAN NORTH

CONSULTANT

A/E:
GDM
1000 W STEUBEN ST. UNIT 3
BINGEN, WA 98605
541.436.4723
ADAM GOODIN, PE

GDM
ARCHITECTS • ENGINEERS

DRAWING TITLE

ELECTRICAL DEMOLITION PLANS -
BLDG 6

APPROVED: Project Director

PROJECT TITLE		
EHRM INFRASTRUCTURE UPGRADES		
LOCATION		
HOT SPRINGS, SOUTH DAKOTA		
ISSUE DATE	CHECKED BY	DRAWN BY
2/22/2022	JAM	CSZ

PROJECT NUMBER 568A4-21-702
BUILDING NUMBER 06
DRAWING NUMBER 006-ED-0B1


- A. THE INFORMATION SHOWN ON THIS DRAWING IS TAKEN FROM RECORD DRAWINGS AND A NON-DESTRUCTIVE WALK THROUGH OF THE FACILITY. THERE IS NO WARRANTY OR GUARANTEE AS TO THE ACCURACY OF THE INFORMATION SHOWN HERE-IN. THE CONTRACTOR SHALL FIELD VERIFY ALL ITEMS SCHEDULED FOR DEMOLITION PRIOR TO START OF WORK.
- B. THE OWNER SHALL HAVE FIRST RIGHT OF REFUSAL ON ALL SALVAGEABLE MATERIALS. THE CONTRACTOR SHALL DELIVER SALVAGED MATERIALS TO A WAREHOUSE AS DIRECTED BY THE OWNER. THE CONTRACTOR SHALL DISPOSE OF, OFF SITE, ALL UNWANTED MATERIALS.
- C. DASHED OR DOTTED LINES INDICATE ITEMS TO BE REMOVED. SOLID LINES INDICATE EXISTING ITEMS TO REMAIN.
- D. LIGHTING AND RECEPTACLES SHALL REMAIN IN EXISTING TELECOM ROOMS. NO DEMOLITION UNLESS OTHERWISE NOTED.

GENERAL NOTES:


- A. THE INFORMATION SHOWN ON THIS DRAWING IS TAKEN FROM RECORD DRAWINGS AND A NON-DESTRUCTIVE WALK THROUGH OF THE FACILITY. THERE IS NO WARRANTY OR GUARANTEE AS TO THE ACCURACY OF THE INFORMATION SHOWN HERE-IN. THE CONTRACTOR SHALL FIELD VERIFY ALL ITEMS SCHEDULED FOR DEMOLITION PRIOR TO START OF WORK.
- B. THE OWNER SHALL HAVE FIRST RIGHT OF REFUSAL ON ALL SALVAGEABLE MATERIALS. THE CONTRACTOR SHALL DELIVER SALVAGED MATERIALS TO A WAREHOUSE AS DIRECTED BY THE OWNER. THE CONTRACTOR SHALL DISPOSE OF, OFF SITE, ALL UNWANTED MATERIALS.
- C. DASHED OR DOTTED LINES INDICATE ITEMS TO BE REMOVED. SOLID LINES INDICATE EXISTING ITEMS TO REMAIN.
- D. LIGHTING AND RECEPTACLES SHALL REMAIN IN EXISTING TELECOM ROOMS. NO DEMOLITION UNLESS OTHERWISE NOTED.

SHEET NOTES:

1. DEMOLISH SWITCHES, LIGHTING, AND RECEPTACLES IN ROOM. DEMOLISH CIRCUITS TO UPSTREAM JUNCTION BOX TO ALLOW FOR NEW CIRCUITING.

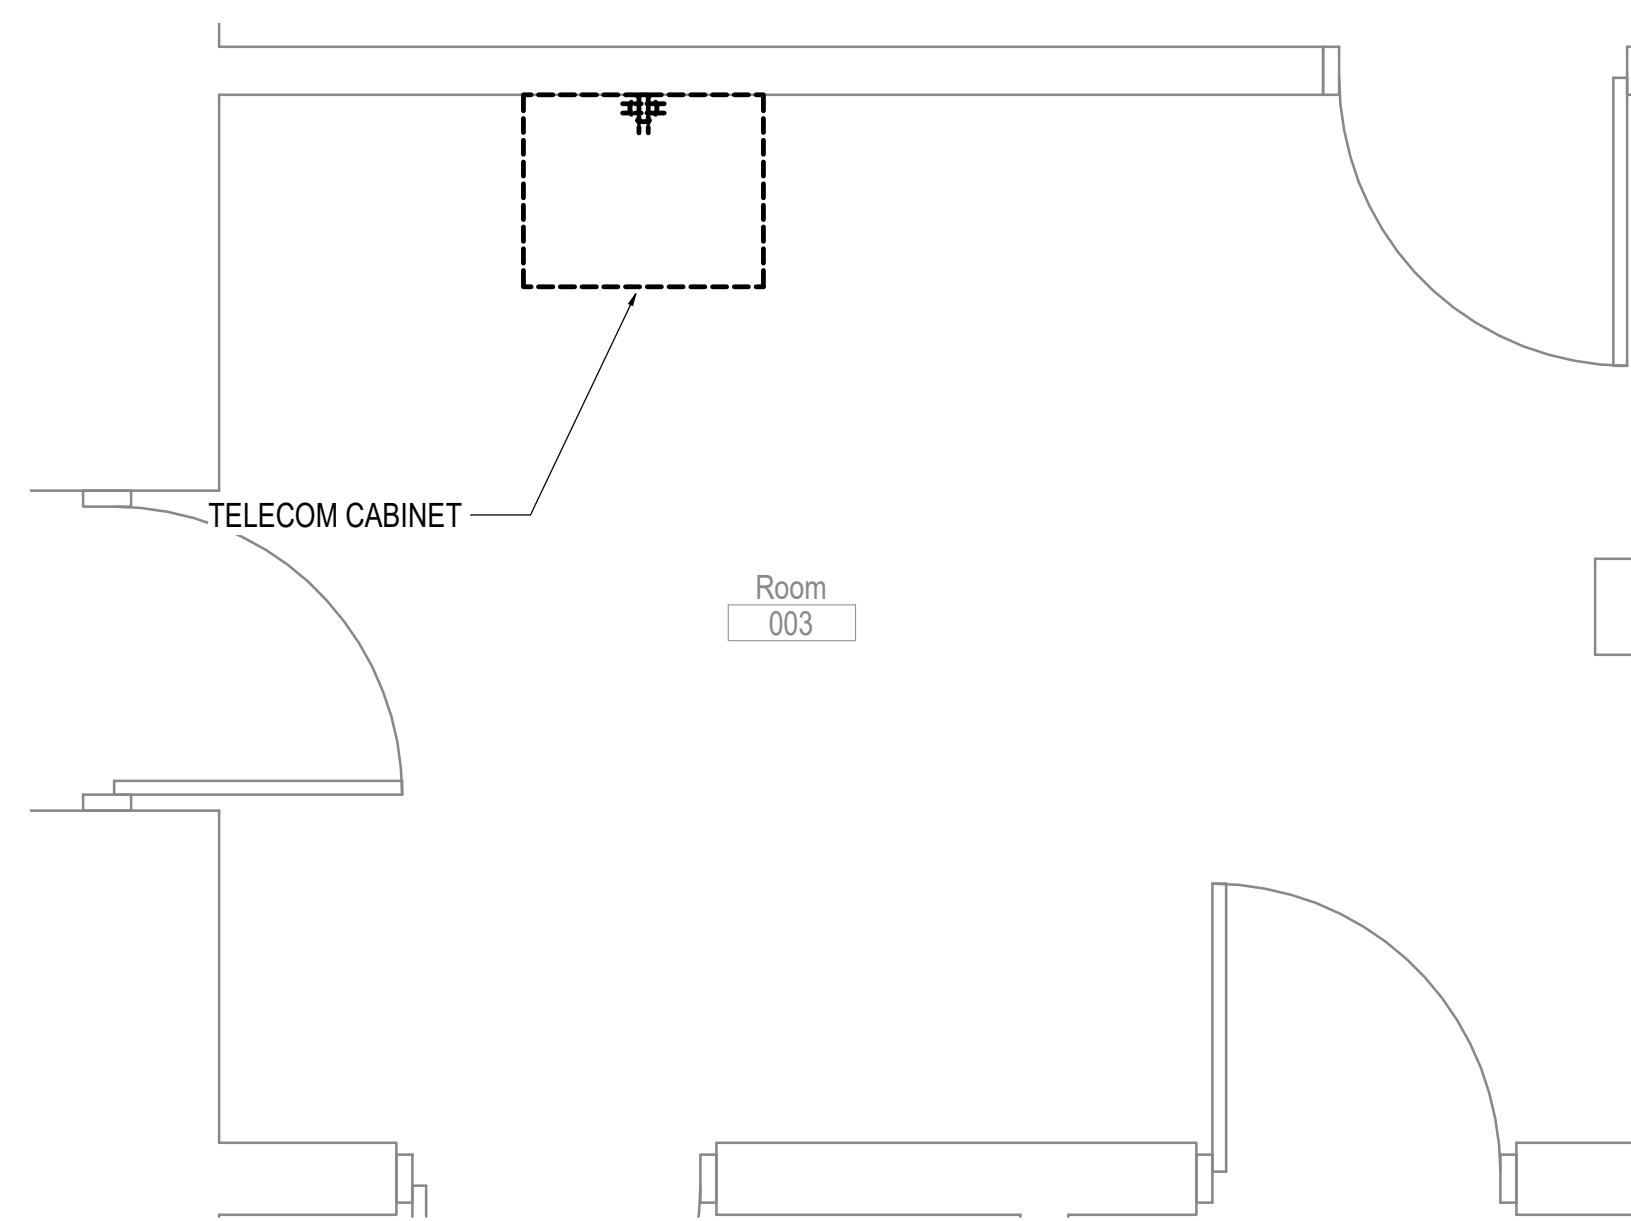


1 ENLARGED ROOM - FOYER ELECTRICAL DEMOLITION
1/2" = 1'-0"

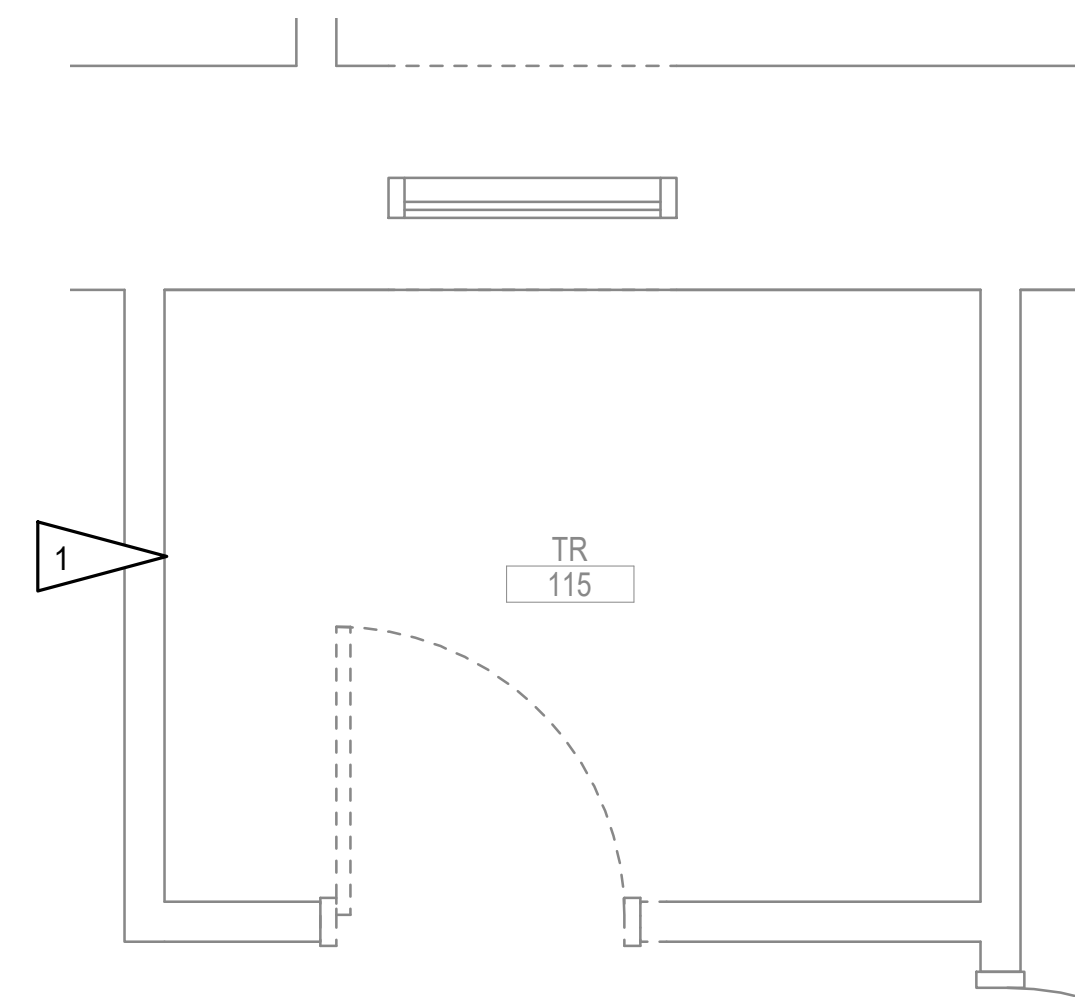

2 ENLARGED ROOM - 115 ELECTRICAL DEMOLITION
1/2" = 1'-0"

SITE LEGEND

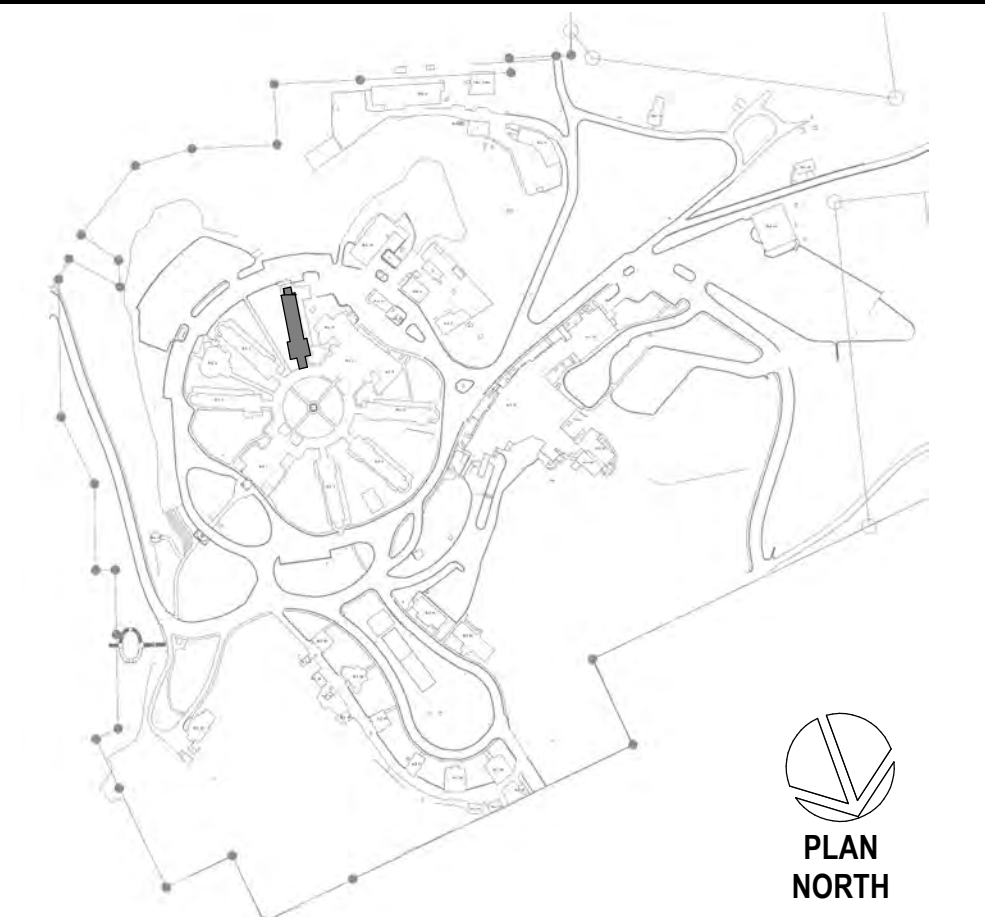[illegible]

CONSULTANT
A/E:
GDM
1000 W STEUBEN ST. UNIT 100
BINGEN, WA 98605
541.436.4723
ADAM GOODIN, PE




ARCHITECT/ENGINEER OF RECORD

R S A

Engineering, Inc.

MECHANICAL AND ELECTRICAL CONSULTING ENGINEERS
670 West Fireweed Lane, Suite 200
Anchorage, AK 99503
Phone (907) 276-0521
Corporate No.: AECC542

STAMP

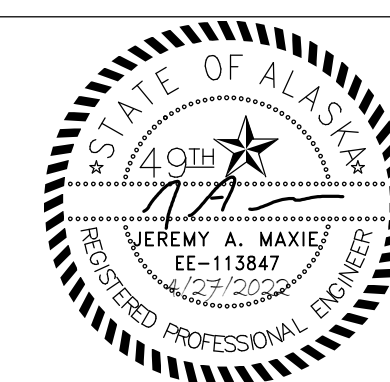

**PROGRAM
CONTRACTING
ACTIVITY
CENTRAL (PCAC)**

VA U.S. Department
of Veterans Affairs

DRAWING TITLE
ENLARGED ELECTRICAL
DEMOLITION PLANS - BLDG 6

APPROVED: Project Director

PHASE
100% CD FINAL SOLUTION

FLS	FULLY SPRINKLERED
-----	-------------------

PROJECT TITLE	EHRM INFRASTRUCTURE UPGRADES
---------------	------------------------------

LOCATION		HOT SPRINGS, SOUTH DAKOTA	
ISSUE DATE	CHECKED BY	DRAWN BY	

PROJECT NUMBER
568A4-21-702

BUILDING NUMBER
06


DRAWING NUMBER
006-ED-0B2

GENERAL NOTES:



- A. THE INFORMATION SHOWN ON THIS DRAWING IS TAKEN FROM RECORD DRAWINGS AND A NON-DESTRUCTIVE WALK THROUGH OF THE FACILITY. THERE IS NO WARRANTY OR GUARANTEE AS TO THE ACCURACY OF THE INFORMATION SHOWN HERE-IN. THE CONTRACTOR SHALL FIELD VERIFY ALL ITEMS SCHEDULED FOR DEMOLITION PRIOR TO START OF WORK.
- B. THE OWNER SHALL HAVE FIRST RIGHT OF REFUSAL ON ALL SALVAGEABLE MATERIALS. THE CONTRACTOR SHALL DELIVER SALVAGED MATERIALS TO A WAREHOUSE AS DIRECTED BY THE OWNER. THE CONTRACTOR SHALL DISPOSE OF, OFF SITE, ALL UNWANTED MATERIALS.
- C. DASHED OR DOTTED LINES INDICATE ITEMS TO BE REMOVED. SOLID LINES INDICATE EXISTING ITEMS TO REMAIN.
- D. LIGHTING AND RECEPTACLES SHALL REMAIN IN EXISTING TELECOM ROOMS. NO DEMOLITION UNLESS OTHERWISE NOTED.

SHEET NOTES:

1. DEMOLISH SWITCHES, LIGHTING, AND RECEPTACLES IN ROOM. DEMOLISH CIRCUITS TO UPSTREAM JUNCTION BOX TO ALLOW FOR NEW CIRCUITING.

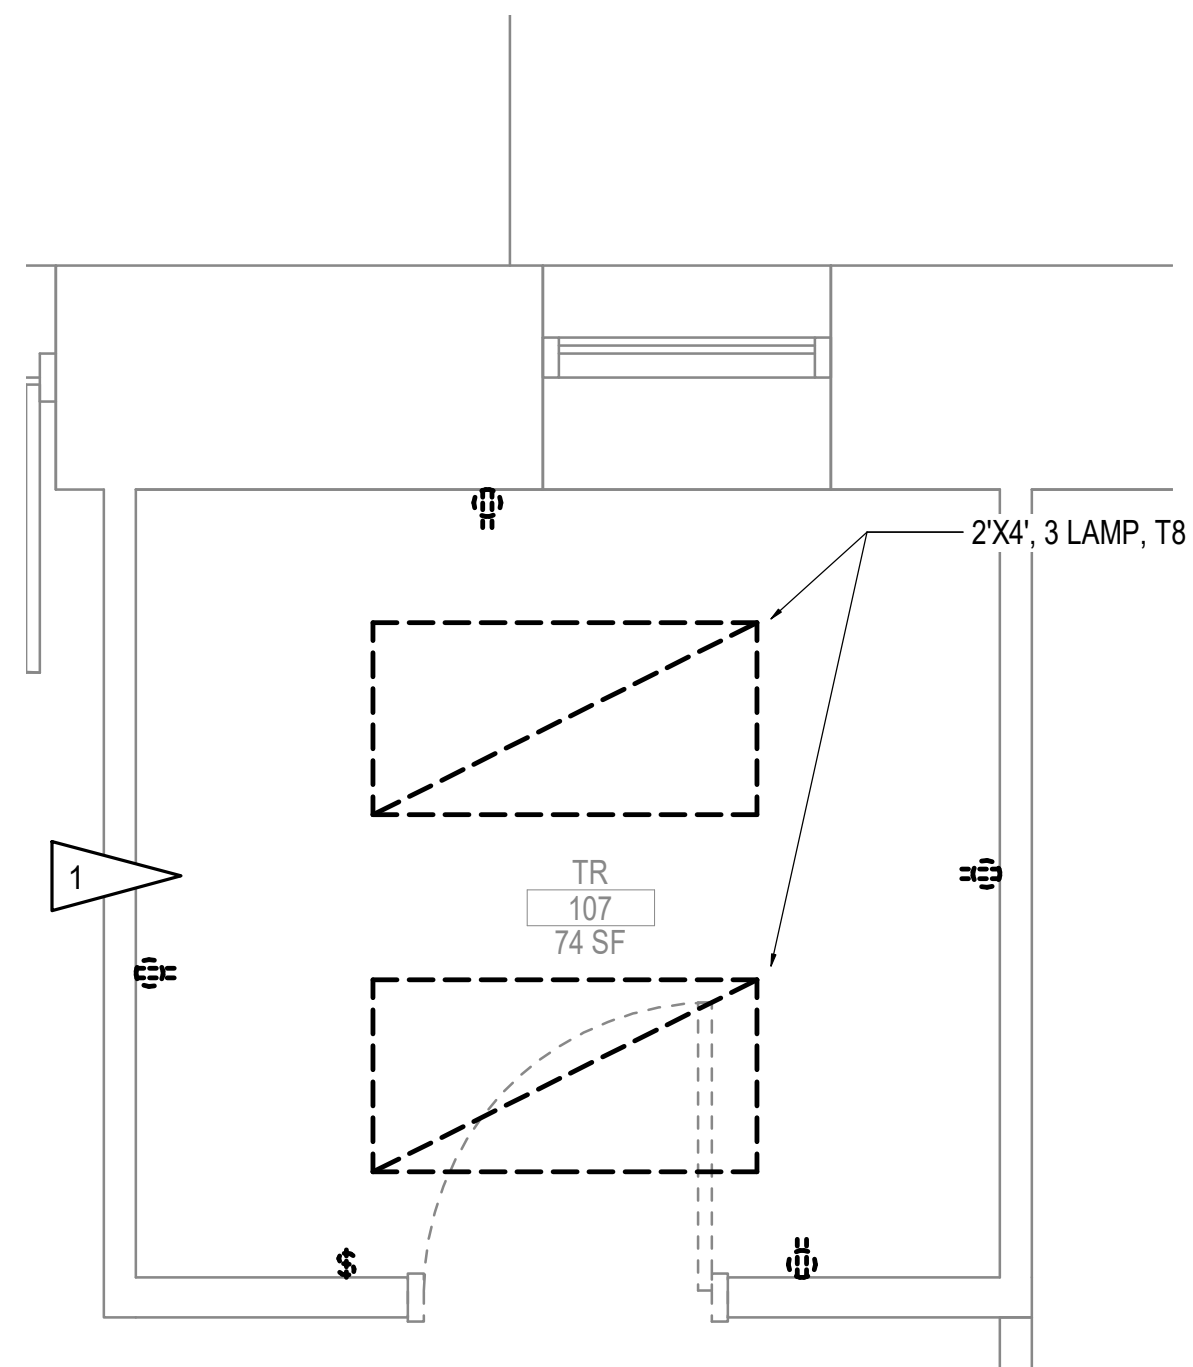


2 ENLARGED ROOM - 107 ELECTRICAL DEMOLITION
1/2" = 1'-0"

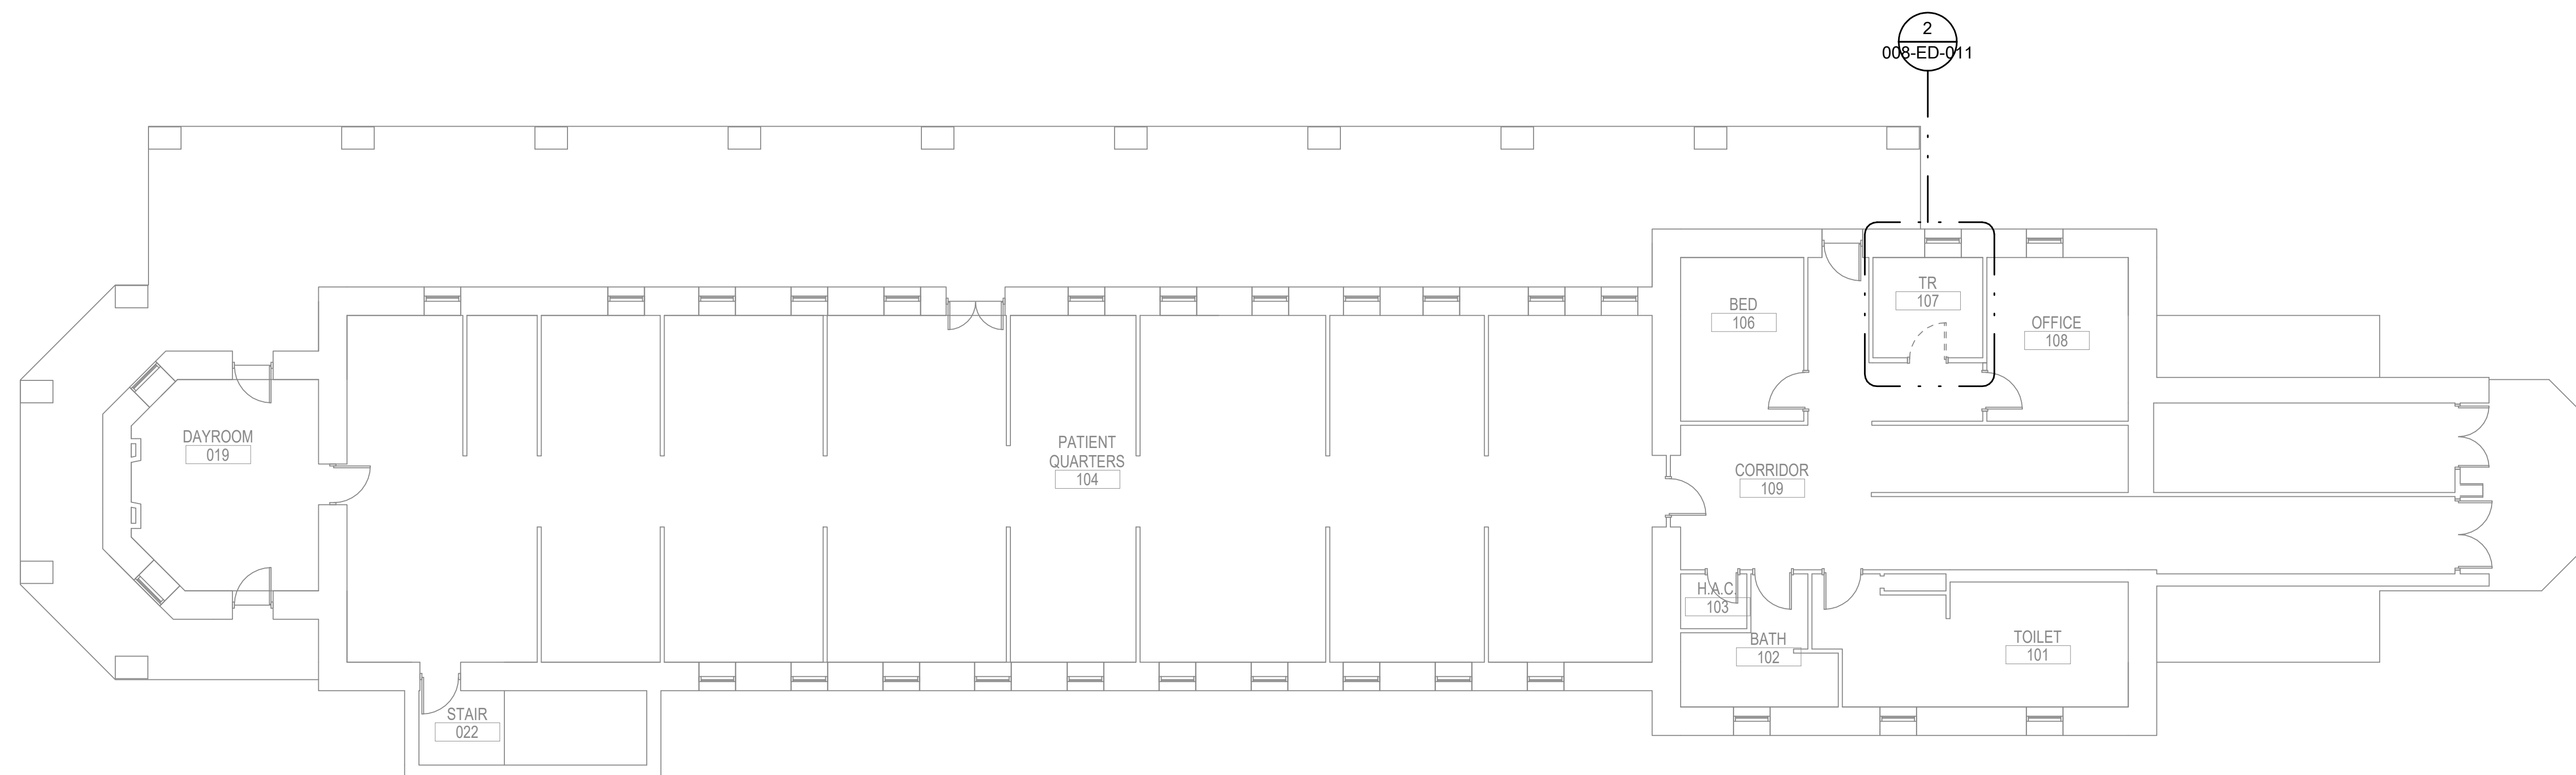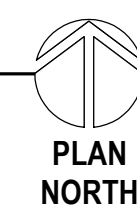

1 ELECTRICAL DEMOLITION PLAN - BLDG 8 FIRST FLOOR
1/8" = 1'-0"



SITE LEGEND

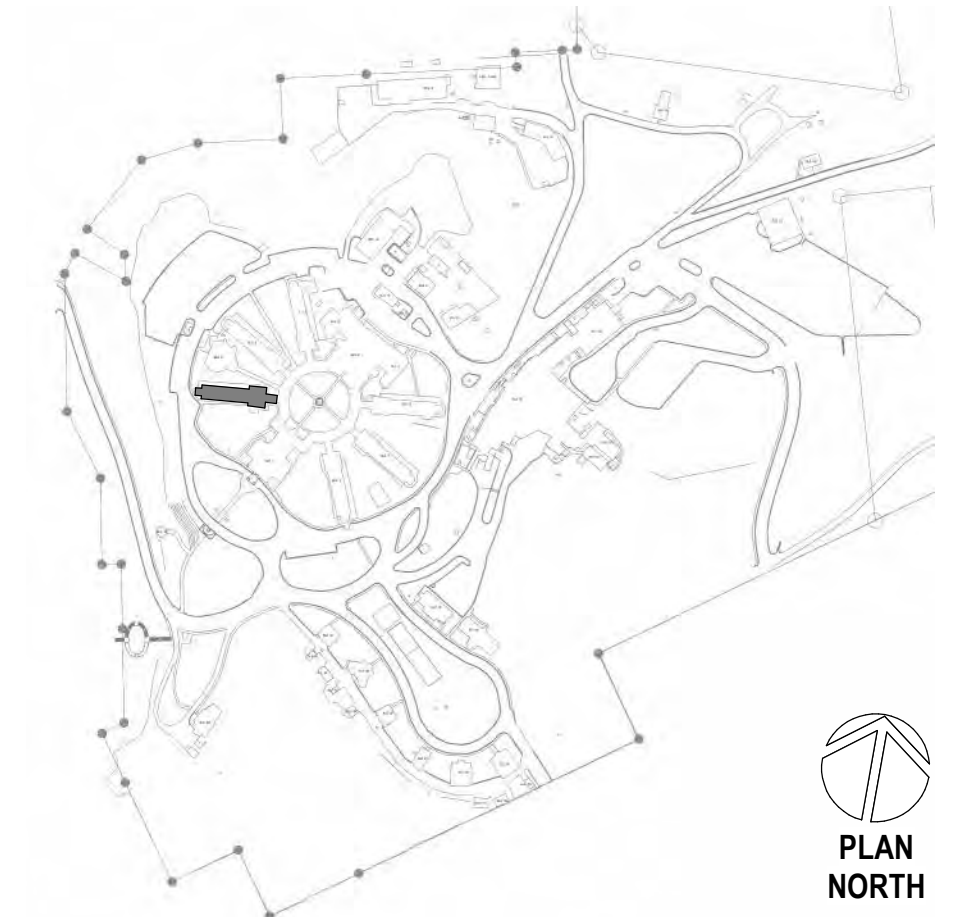[illegible]

CONSULTANT

A/E:
GDM
1000 W STEUBEN ST. UNIT 3
BINGEN, WA 98605
541.436.4723
ADAM GOODIN, PE

GDM
ARCHITECTS • ENGINEERS

ARCHITECT/ENGINEER OF RECORD

R S A

Engineering, Inc.

MECHANICAL AND ELECTRICAL CONSULTING ENGINEERS

670 West Fireweed Lane, Suite 200

Anchorage, AK 99503

Phone (907) 576-0521

Corporate No.: AECC542

STAMP

STATE OF ALASKA
49th
JEREMY A. MAXIE
EE-113847
9/22/23
REGISTERED PROFESSIONAL ENGINEER

**PROGRAM
CONTRACTING
ACTIVITY
CENTRAL (PCAC)**

VA | U.S. Department
of Veterans Affairs

DRAWING TITLE


ELECTRICAL DEMOLITION PLAN -
BLDG 8 FIRST FLOOR

APPROVED: Project Director

PHASE	100% CD FINAL SOLUTION
FLS	FULLY SPRINKLERED

PROJECT TITLE			PI
EHRM INFRASTRUCTURE UPGRADES			BI
LOCATION			DI
HOT SPRINGS, SOUTH DAKOTA			
ISSUE DATE	CHECKED BY	DRAWN BY	
2/22/2022	JAM	CSZ	


PROJECT NUMBER
568A4-21-702
BUILDING NUMBER
08
DRAWING NUMBER
008-ED-011

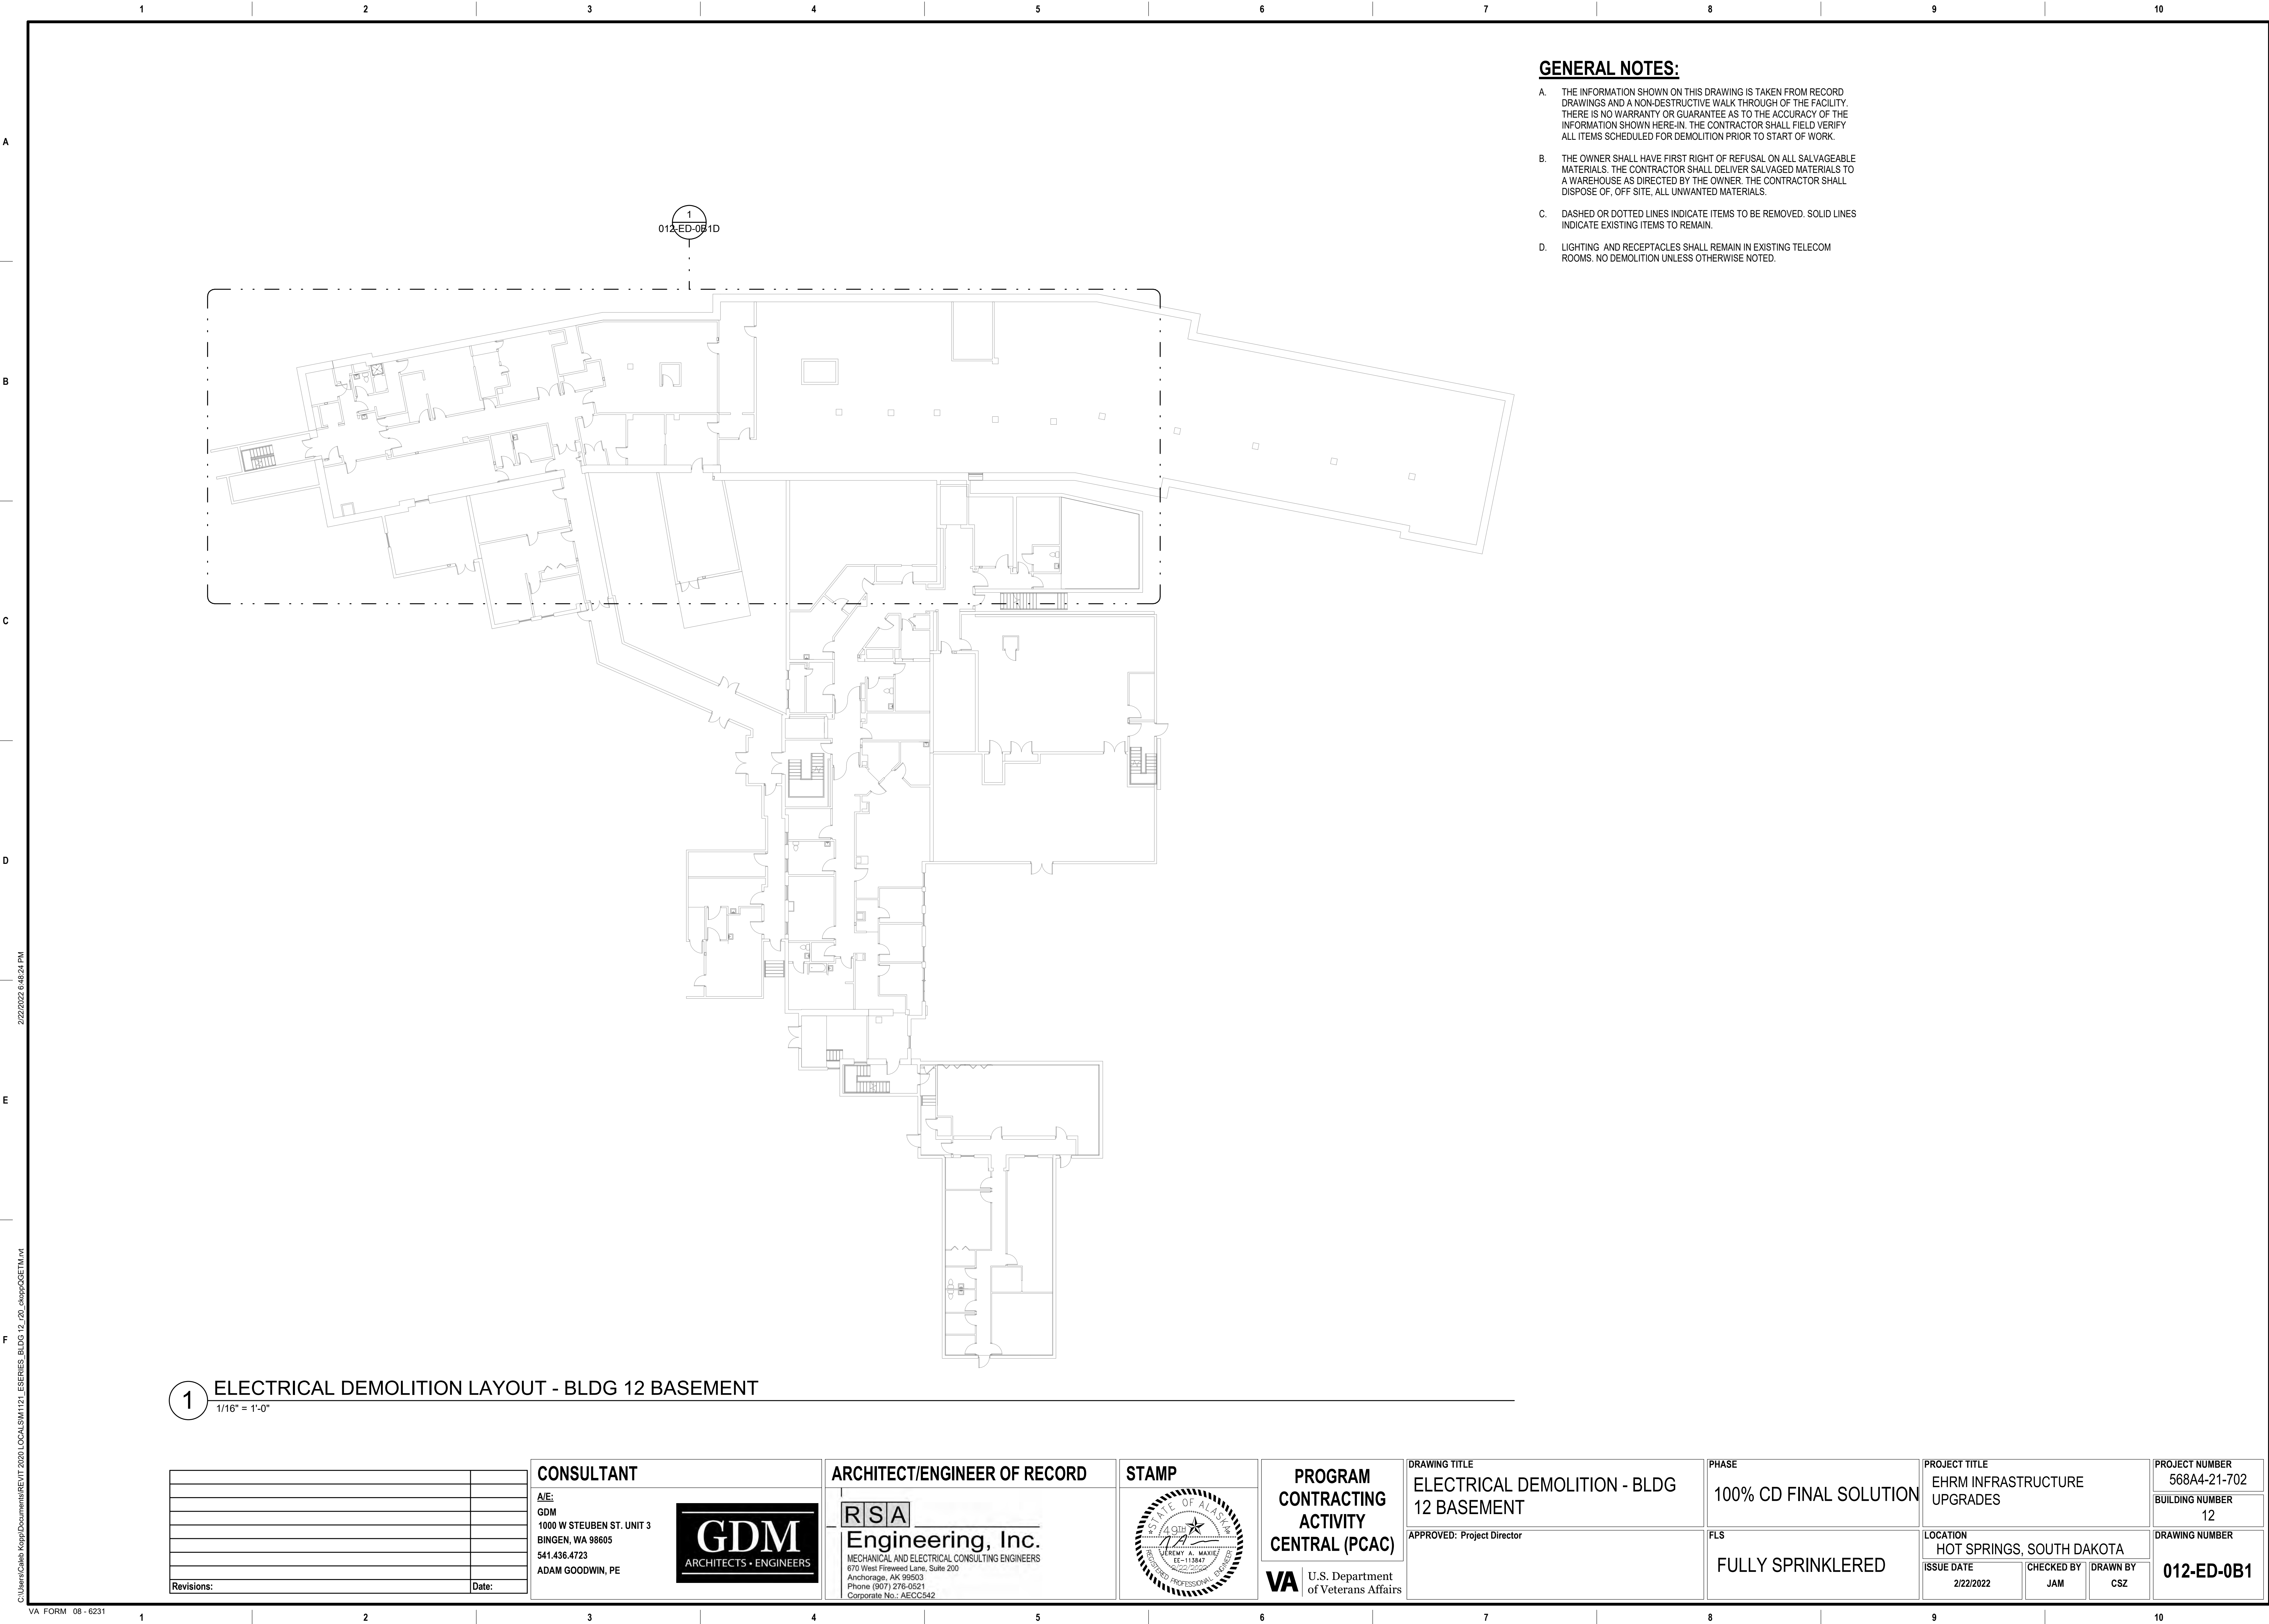

A. SEE SHEET 012-ED-0B1 FOR GENERAL NOTES.





PROJECT NUMBER
568A4-21-702
BUILDING NUMBER
12
DRAWING NUMBER
012-ED-0B1D

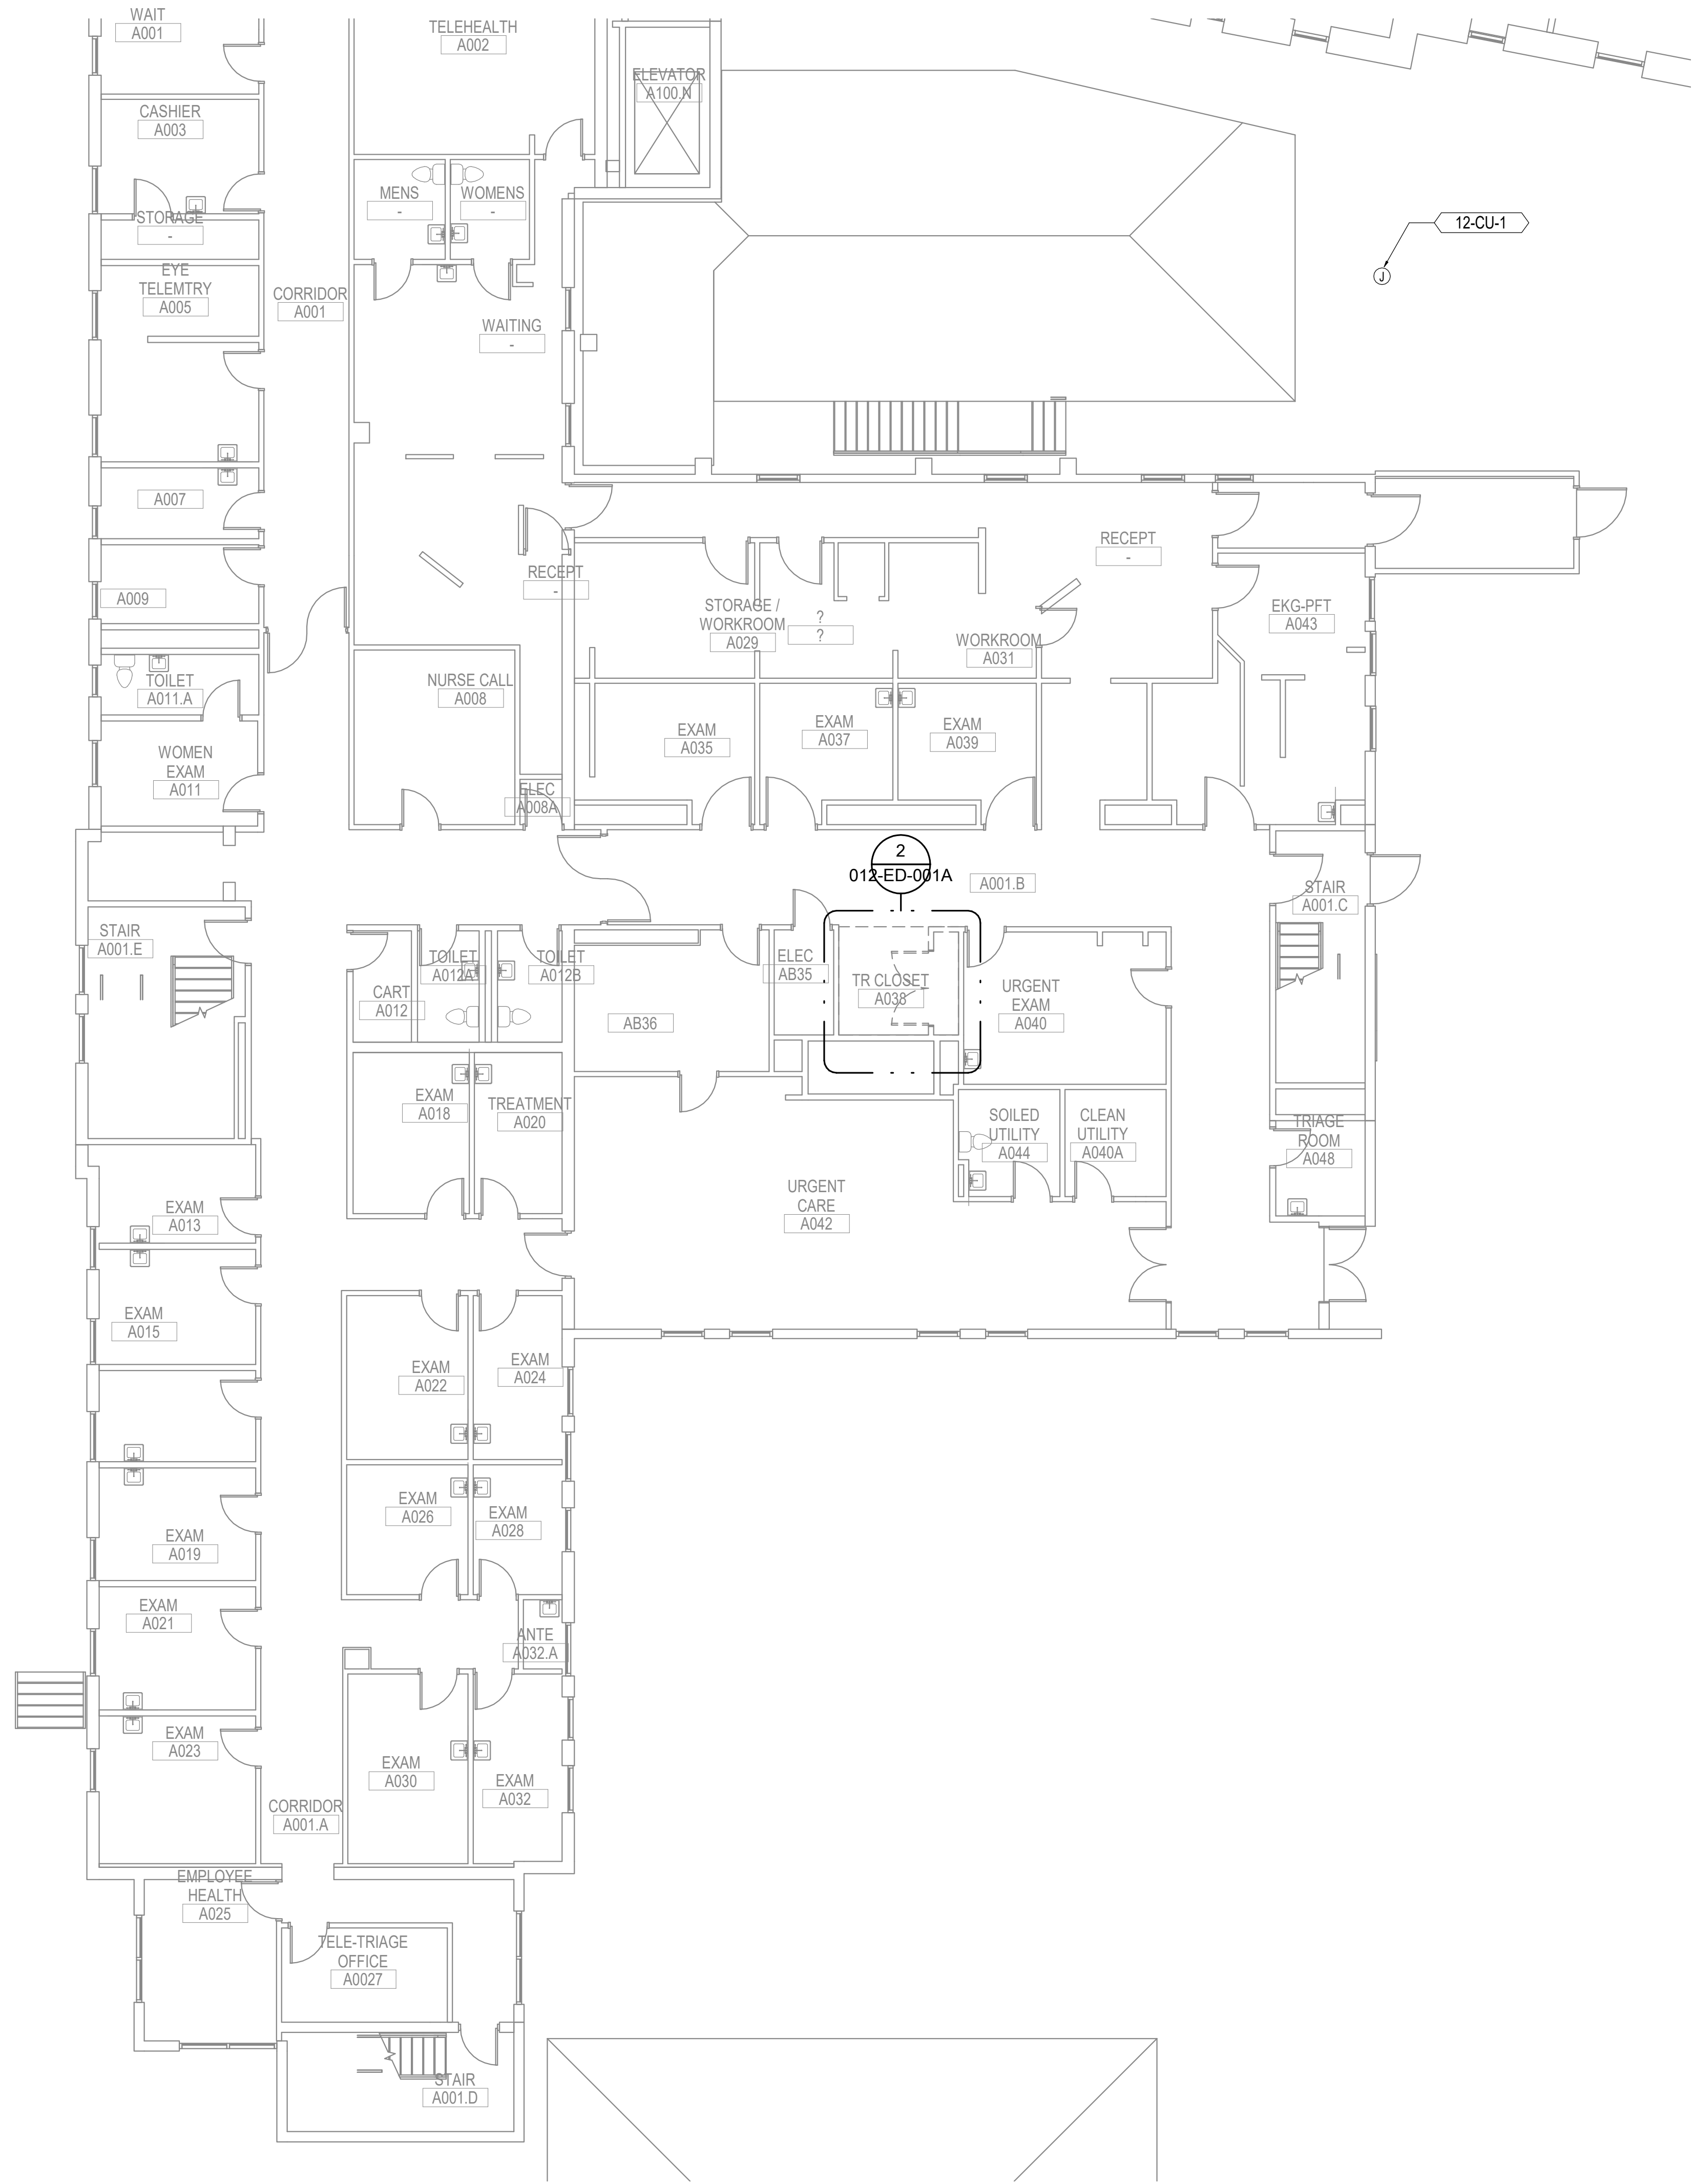

1 ELECTRICAL DEMOLITION PLAN - BLDG 12 GROUND FLOOR SECTOR A
1/8" = 1'-0"



2 ENLARGED ROOM - A038 ELECTRICAL DEMOLITION
1/2" = 1'-0"

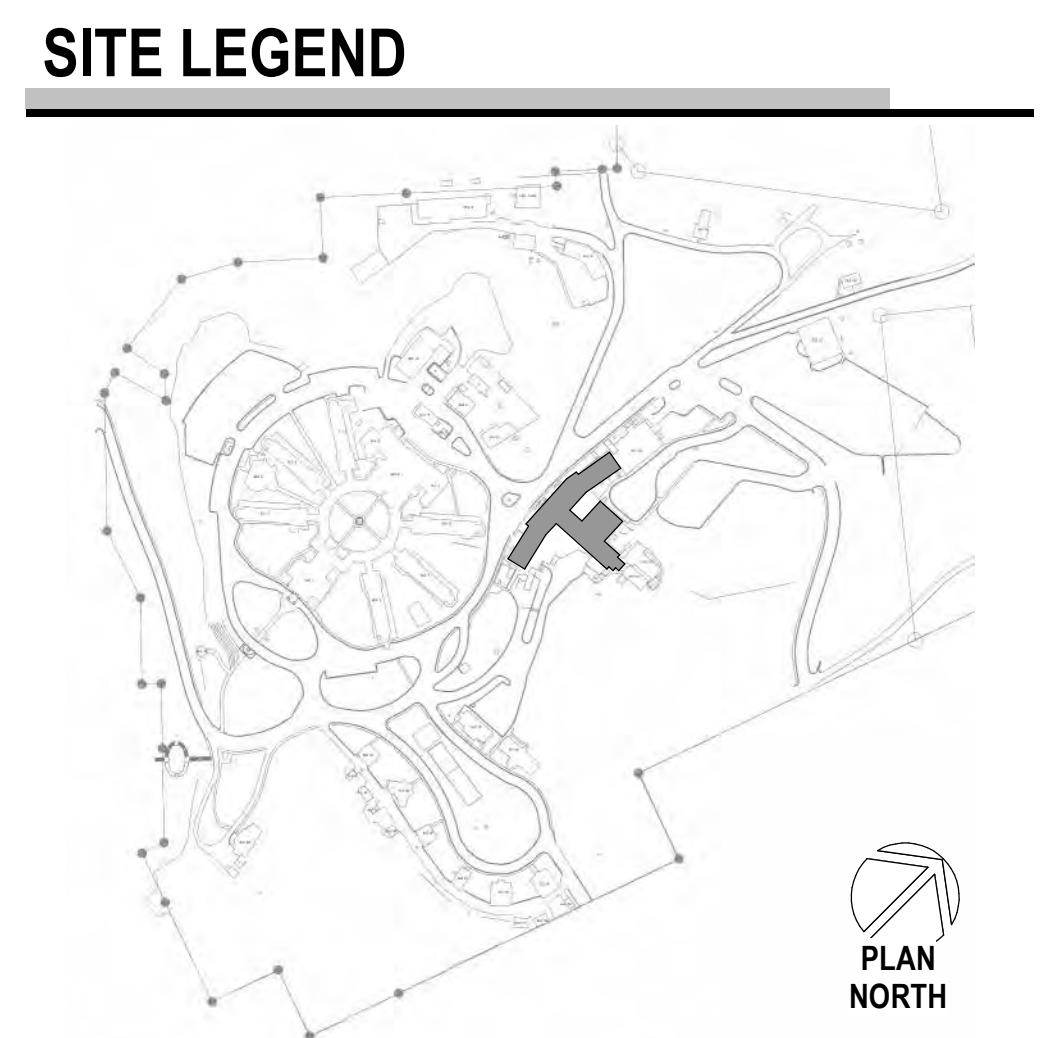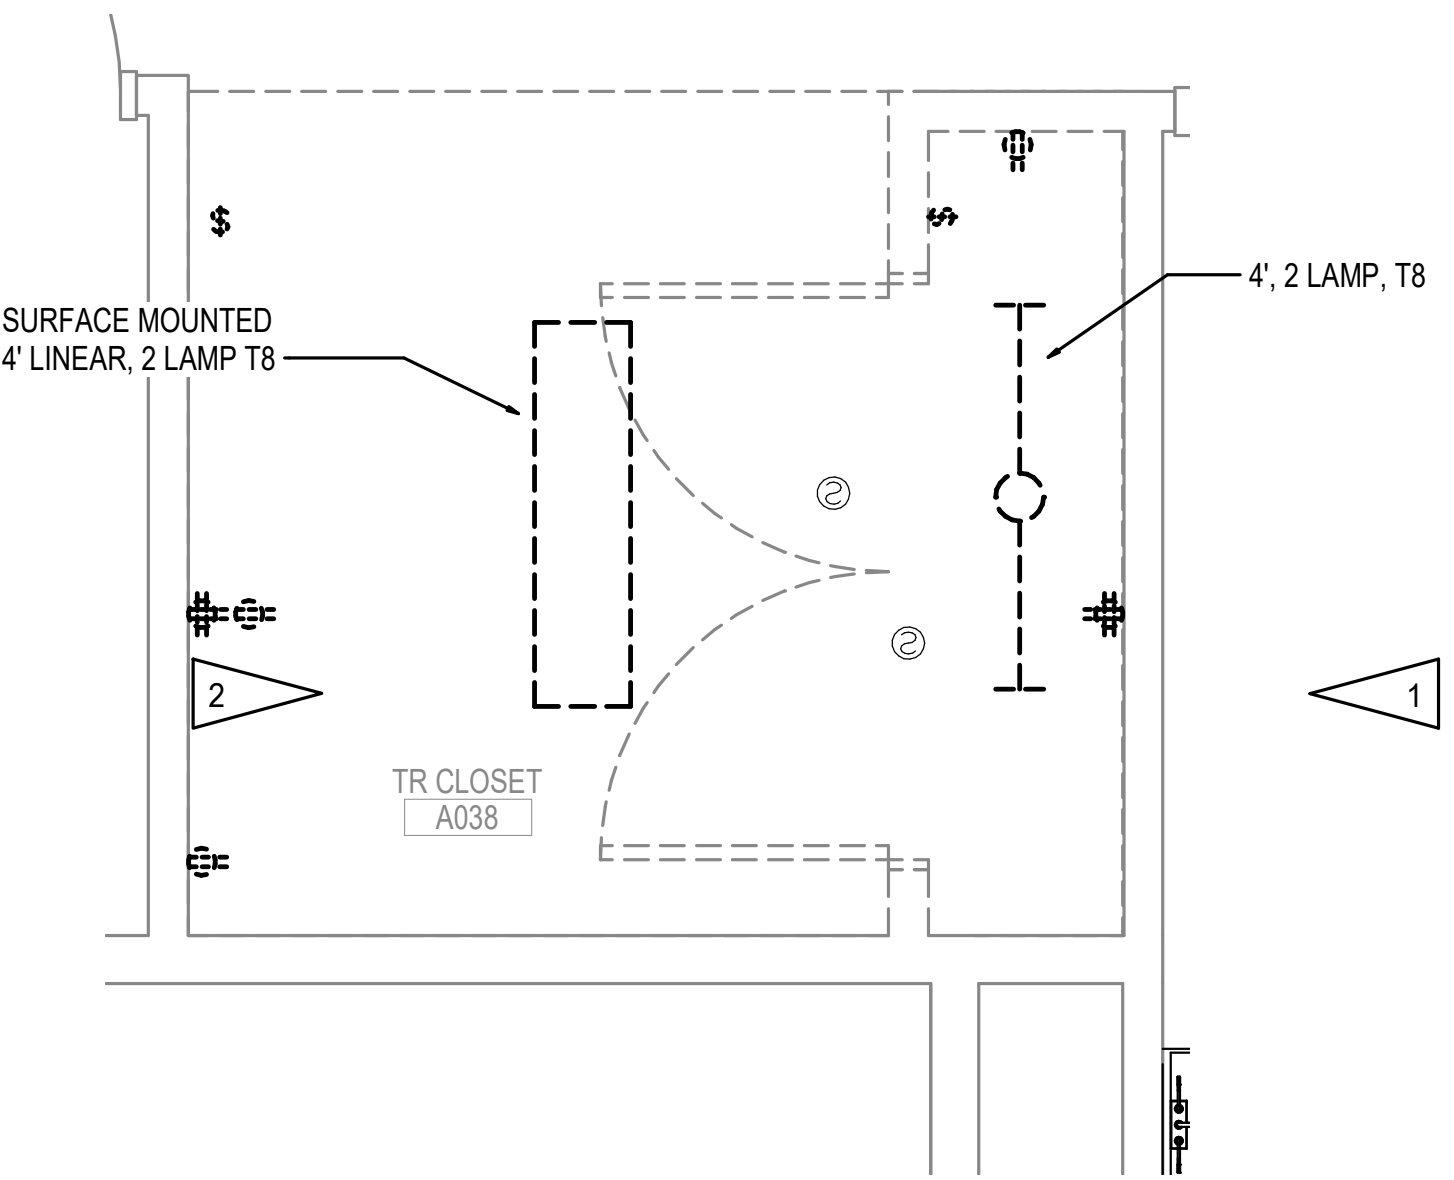

GENERAL NOTES:

- A. SEE SHEET 012-ED-001 FOR GENERAL NOTES.

SHEET NOTES:

1. DEMOLISH SWITCHES, LIGHTING, AND RECEPTACLES IN ROOM. DEMOLISH CIRCUITS TO UPSTREAM JUNCTION BOX TO ALLOW FOR NEW CIRCUITING.

Revisions:	Date:

CONSULTANT
A/E:
GDM
1000 W STEUBEN ST. UNIT 3
BINGEN, WA 98605
541.436.4723
ADAM GOODWIN, PE

ARCHITECT/ENGINEER OF RECORD
RSA
Engineering, Inc.
MECHANICAL AND ELECTRICAL CONSULTING ENGINEERS
670 West Firwood Lane, Suite 200
Anchorage, AK 99503
Phone (907) 278-0521
Corporate No.: AECC542

STAMP


PROGRAM CONTRACTING ACTIVITY CENTRAL (PCAC)
U.S. Department of Veterans Affairs

DRAWING TITLE
ELECTRICAL DEMO - BLDG 12 GROUND A ENLARGED
APPROVED: Project Director



PHASE
100% CD FINAL SOLUTION
FLS
FULLY SPRINKLERED

PROJECT TITLE
EHRM INFRASTRUCTURE UPGRADES
LOCATION
HOT SPRINGS, SOUTH DAKOTA
ISSUE DATE
2/22/2022
CHECKED BY
JAM
DRAWN BY
CSZ


PROJECT NUMBER
568A4-21-702
BUILDING NUMBER
12
DRAWING NUMBER
012-ED-001A

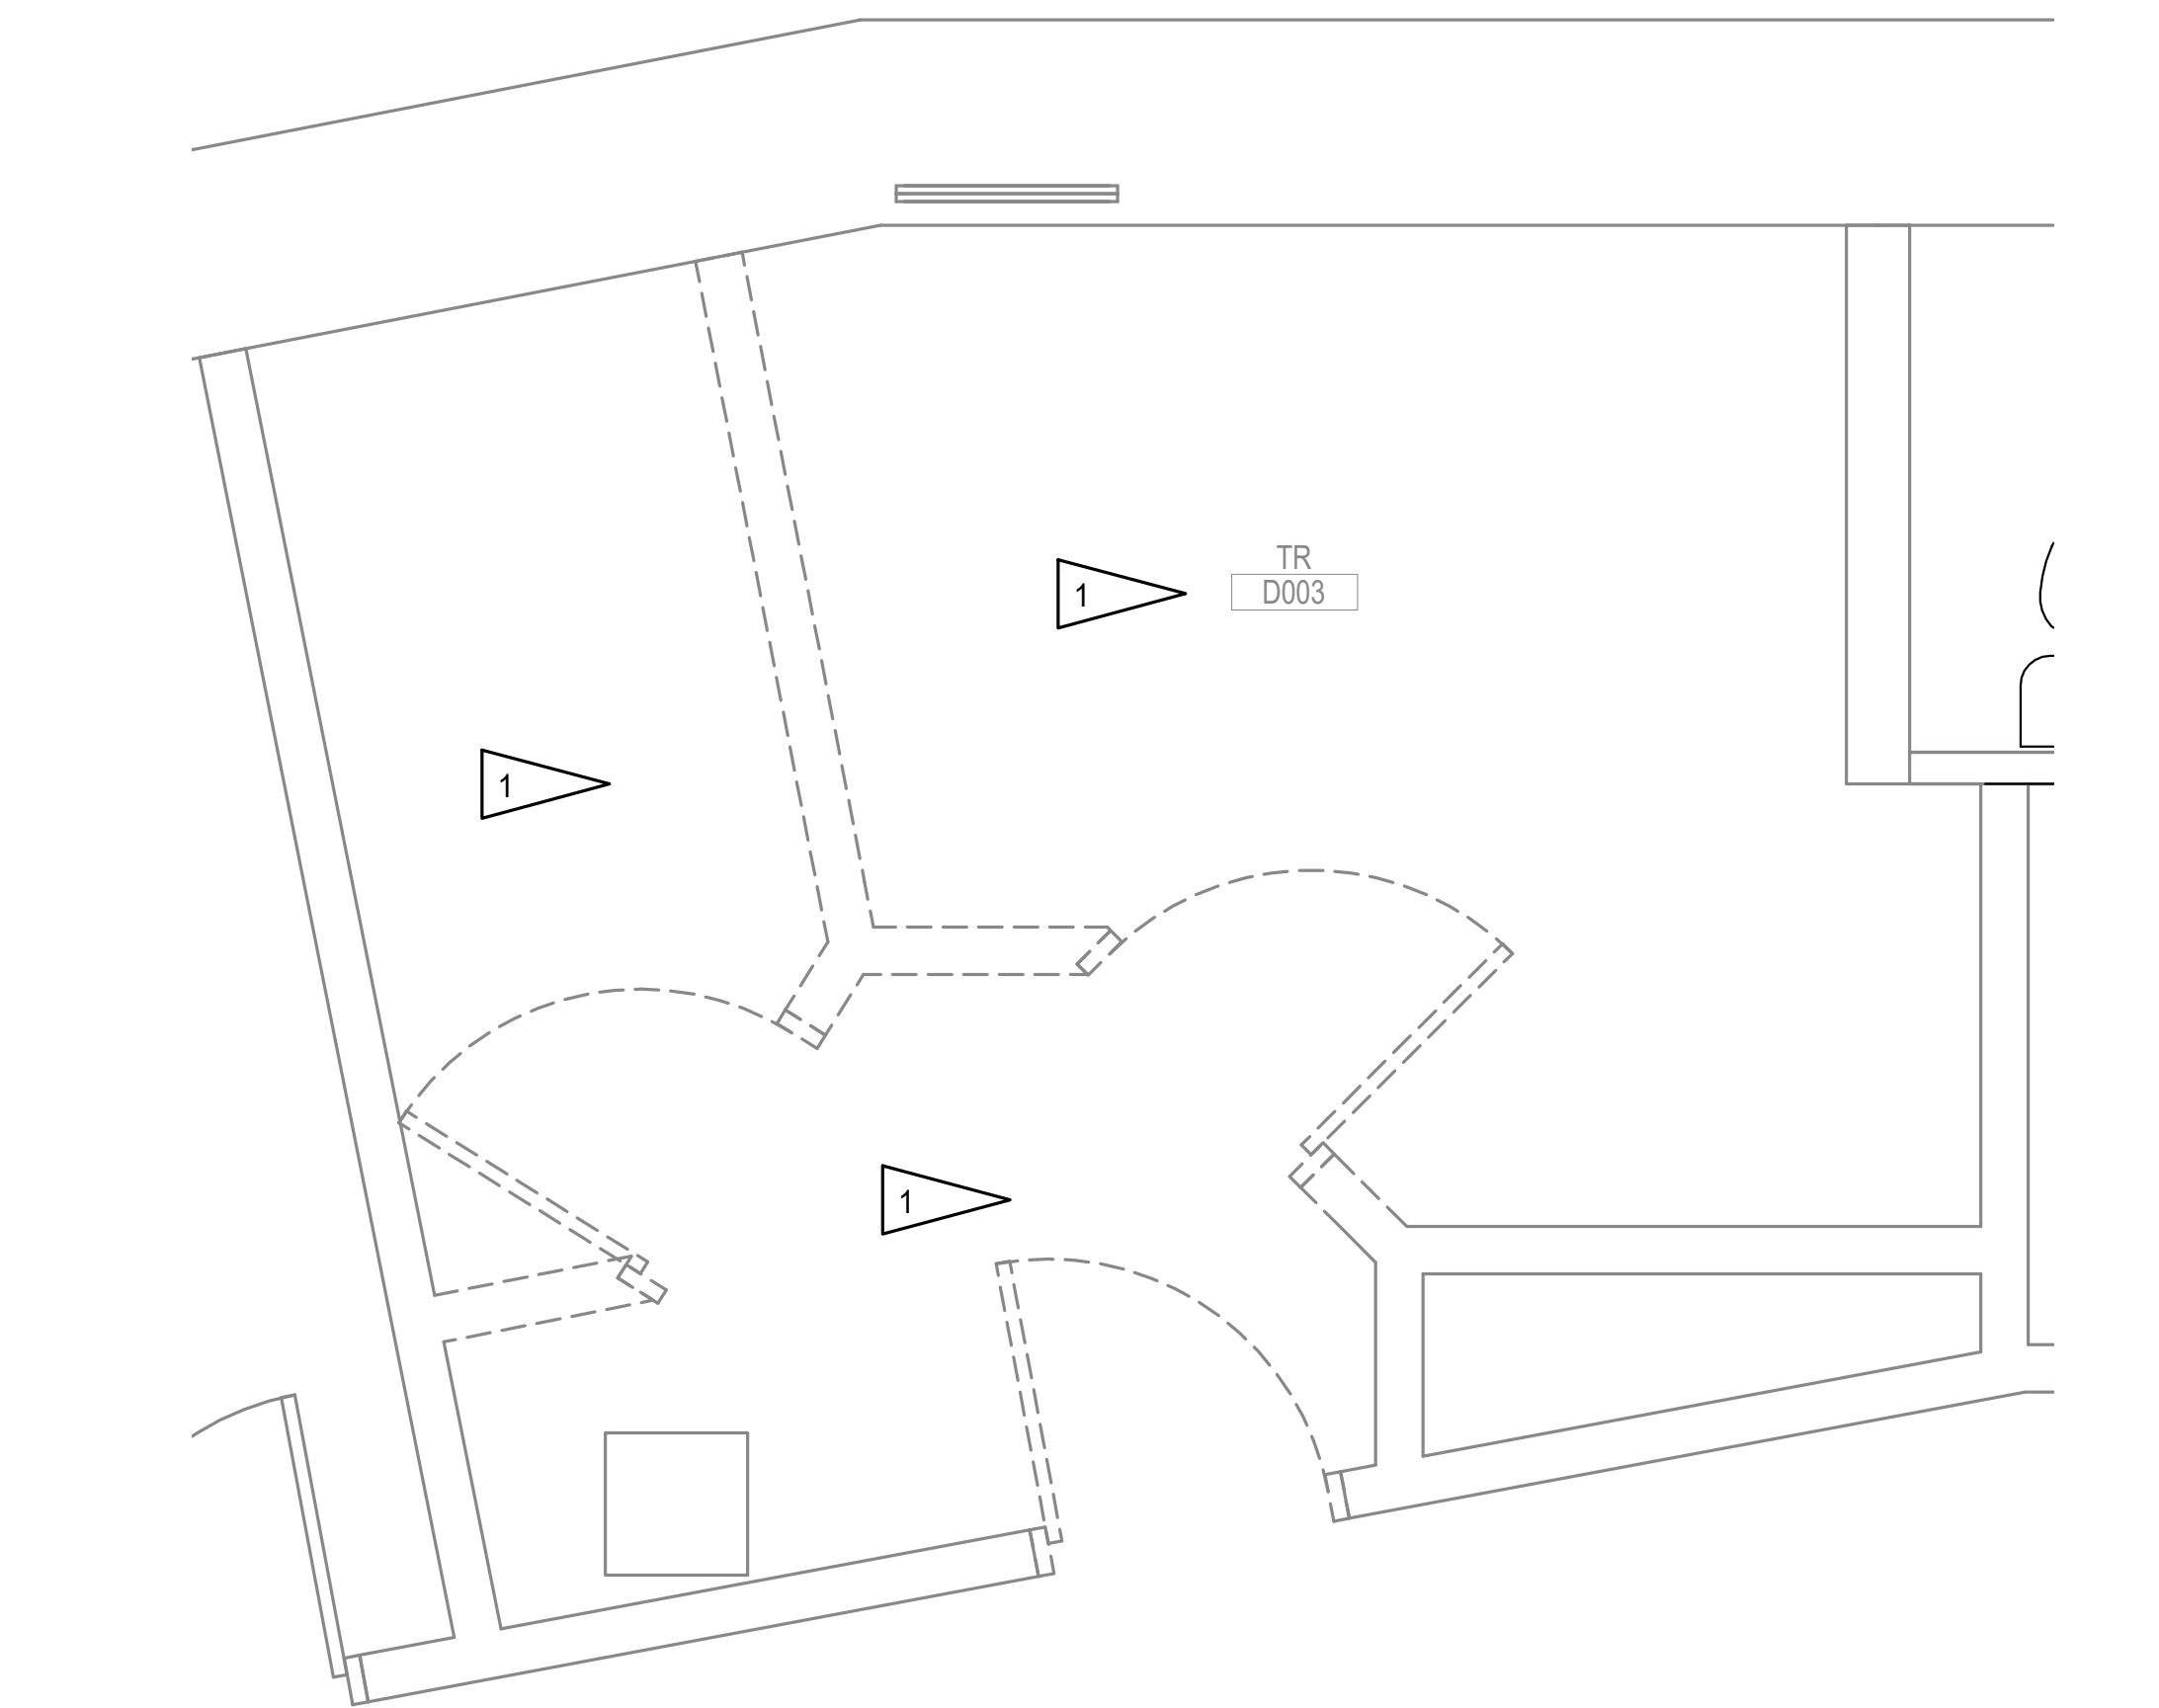


2 ENLARGED ROOM - D003.A ELECTRICAL DEMOLITION
1/2" = 1'-0"

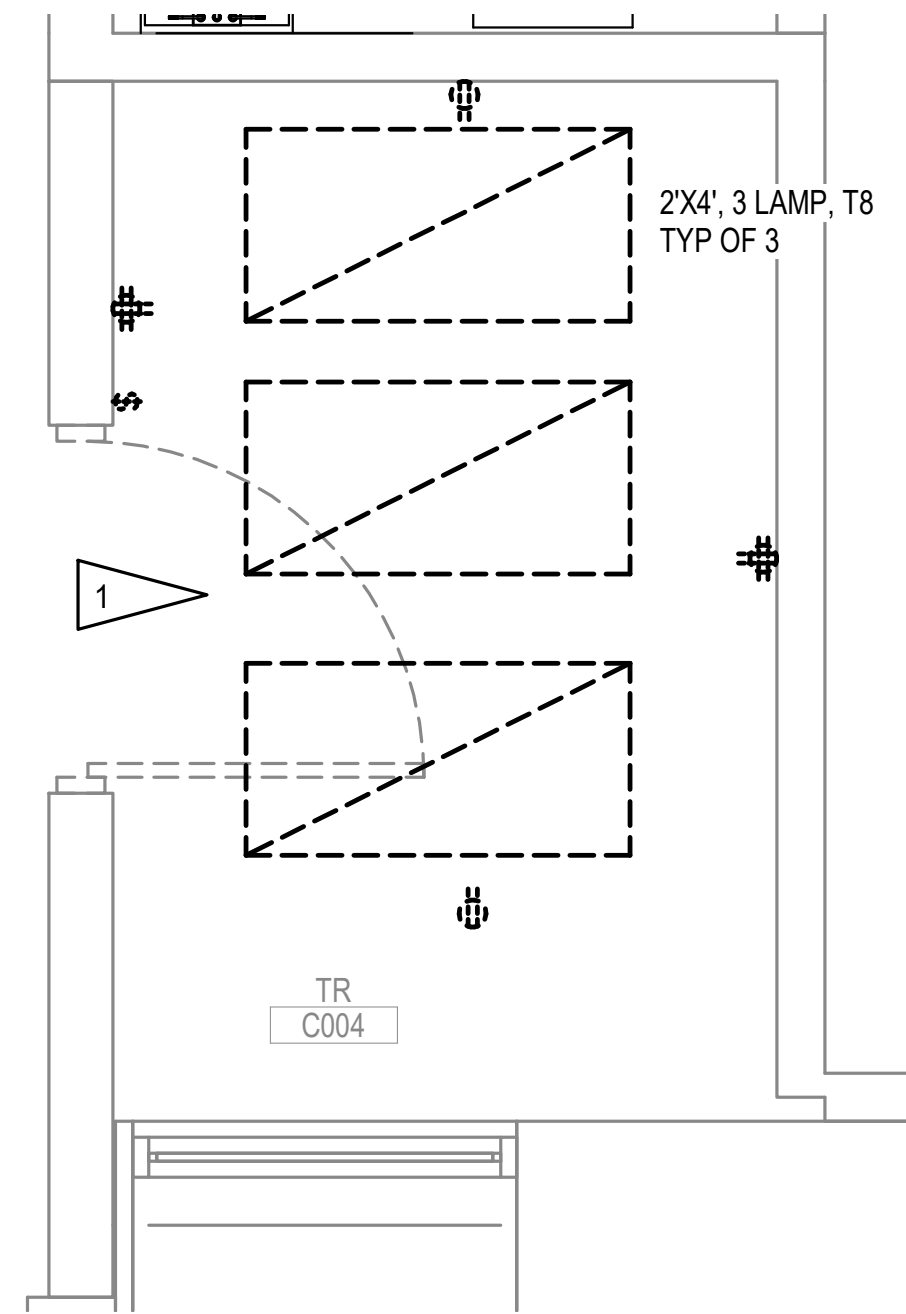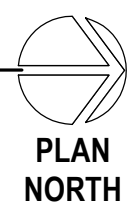


3 ENLARGED ROOM - C004 ELECTRICAL DEMOLITION
1/2" = 1'-0"

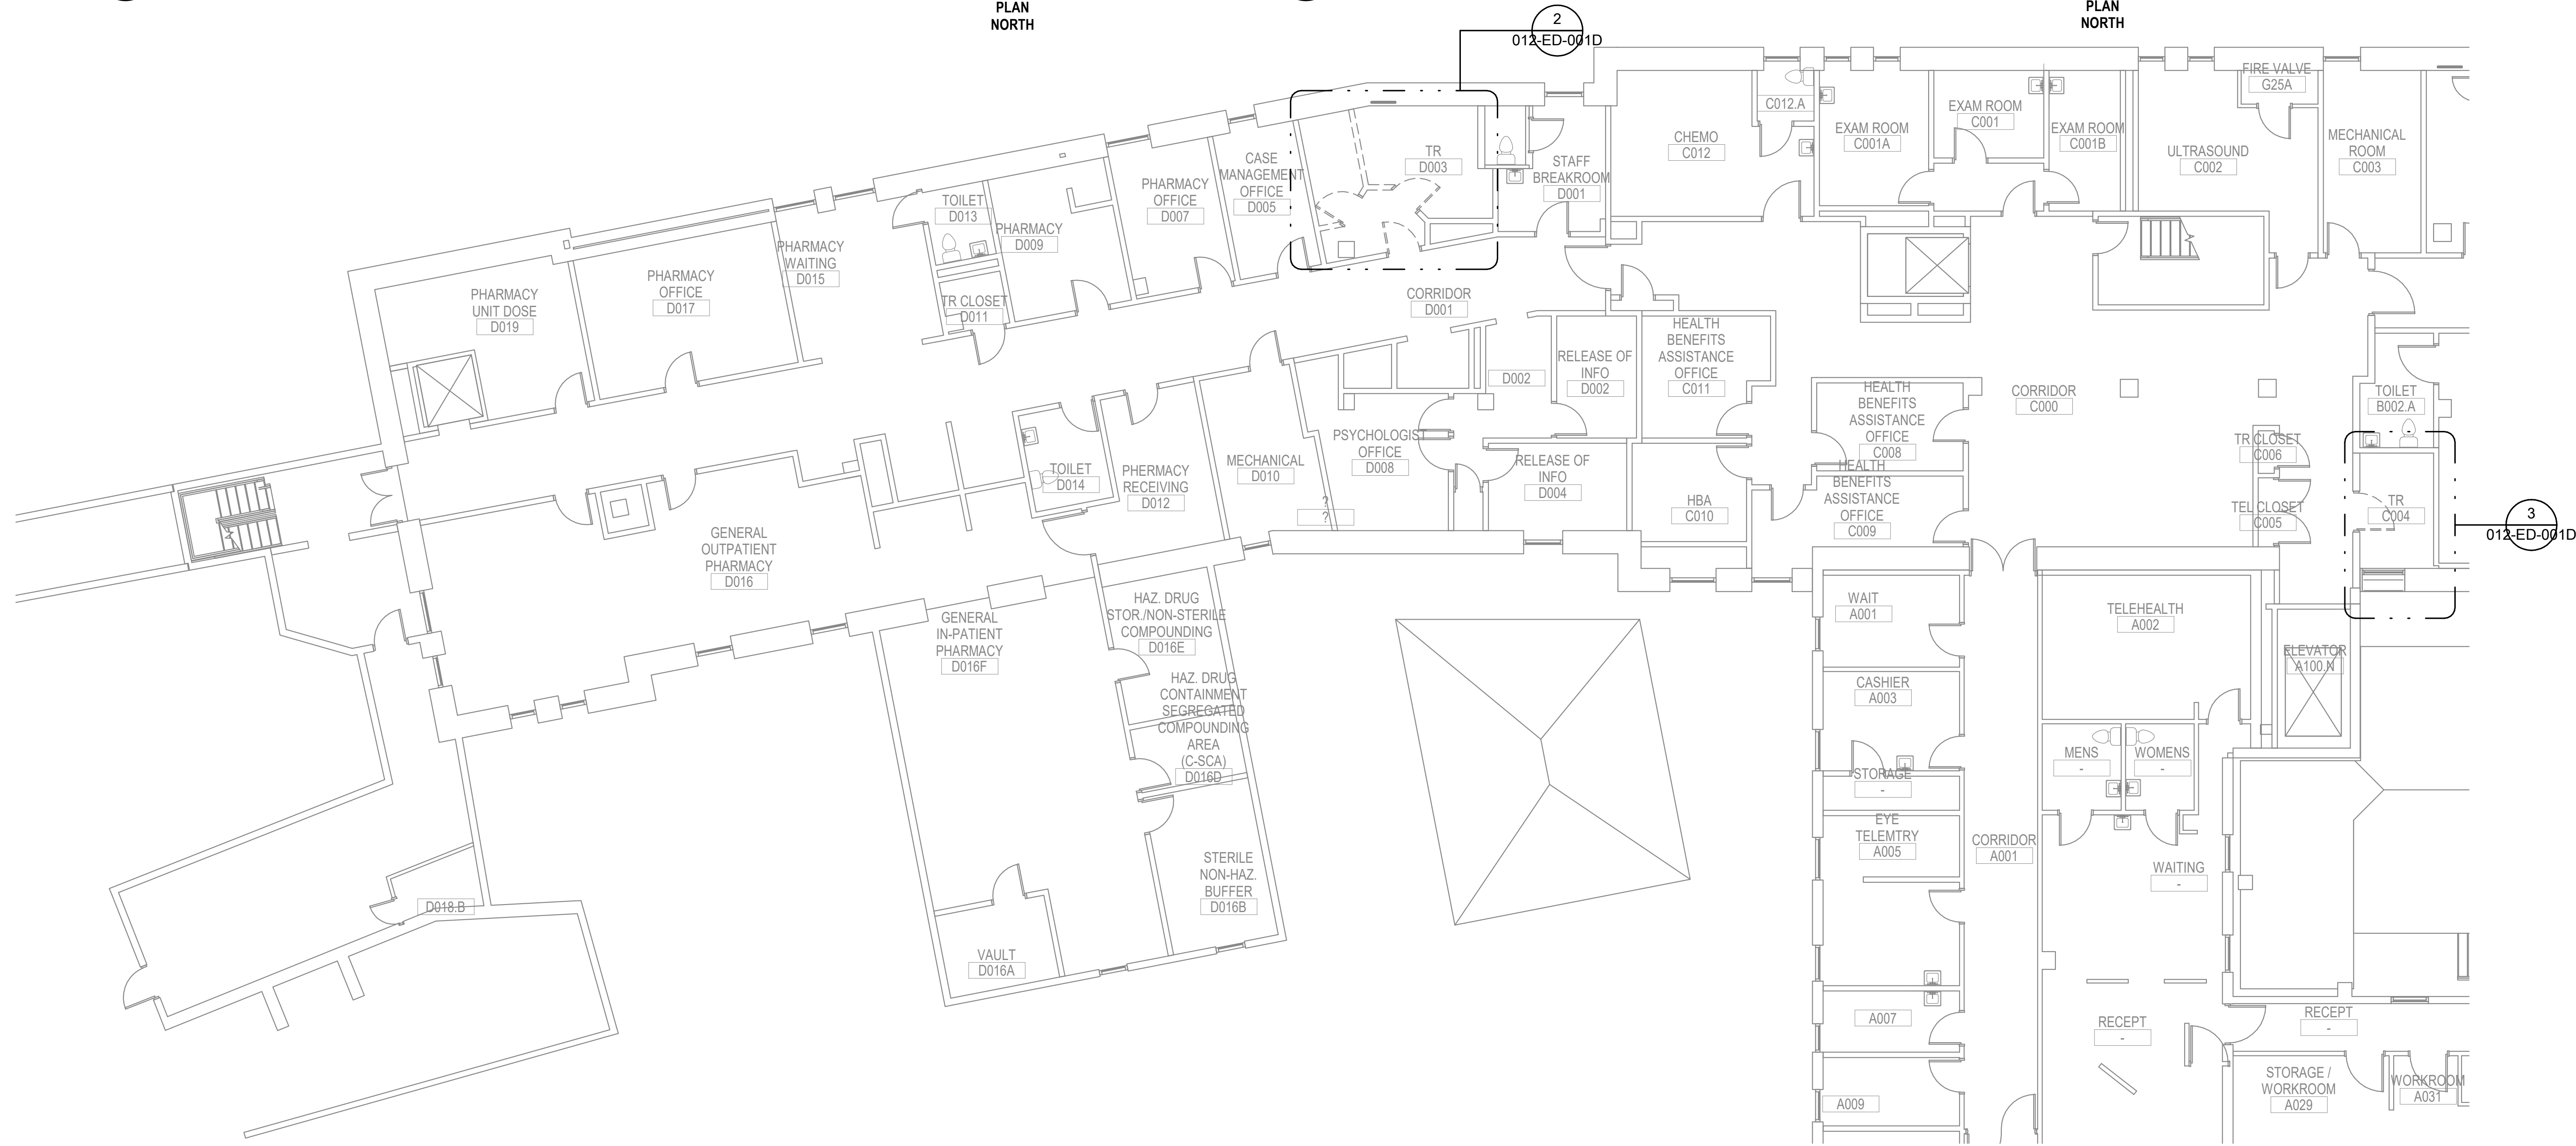

1 ELECTRICAL DEMOLITION PLAN - BLDG 12 GROUND FLOOR SECTOR C AND D
1/8" = 1'-0"

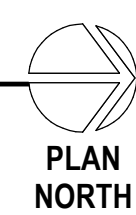

SITE LEGEND

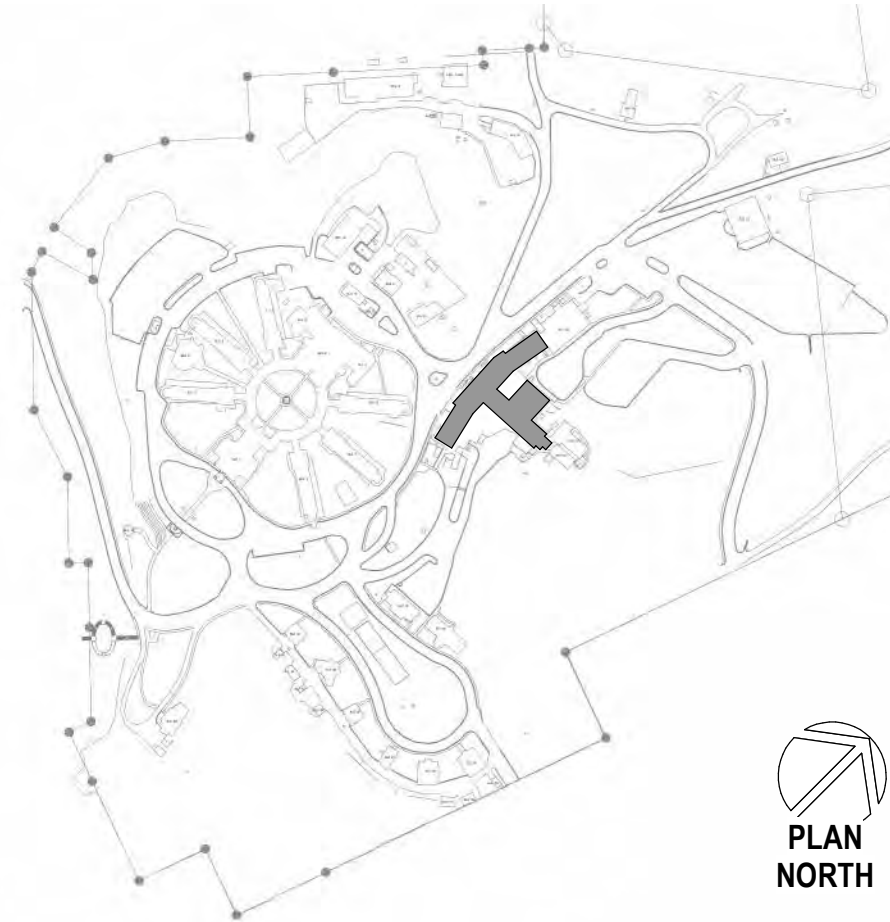

Revisions:	Date:

CONSULTANT

A/E:
GDM
1000 W STEUBEN ST. UNIT 3
BINGEN, WA 98605
541.436.4723
ADAM GOODWIN, PE

GDM
ARCHITECTS • ENGINEERS

ARCHITECT/ENGINEER OF RECORD

RSA
Engineering, Inc.
MECHANICAL AND ELECTRICAL CONSULTING ENGINEERS
670 West Firwood Lane, Suite 200
Anchorage, AK 99503
Phone (907) 278-0521
Corporate No.: AEC0542

STAMP

STATE OF ALASKA
JEREMY A. MAXIE
E-113847
REGISTERED PROFESSIONAL ENGINEER

PROGRAM CONTRACTING ACTIVITY CENTRAL (PCAC)

VA U.S. Department of Veterans Affairs

DRAWING TITLE
ELECTRICAL DEMO - BLDG 12 GROUND C/D ENLARGED

APPROVED: Project Director

PHASE
100% CD FINAL SOLUTION

FLS
FULLY SPRINKLERED

PROJECT TITLE
EHRM INFRASTRUCTURE UPGRADES

LOCATION
HOT SPRINGS, SOUTH DAKOTA

ISSUE DATE
2/22/2022


CHECKED BY
JAM

DRAWN BY
CSZ

PROJECT NUMBER
568A4-21-702

BUILDING NUMBER
12


DRAWING NUMBER
012-ED-001D

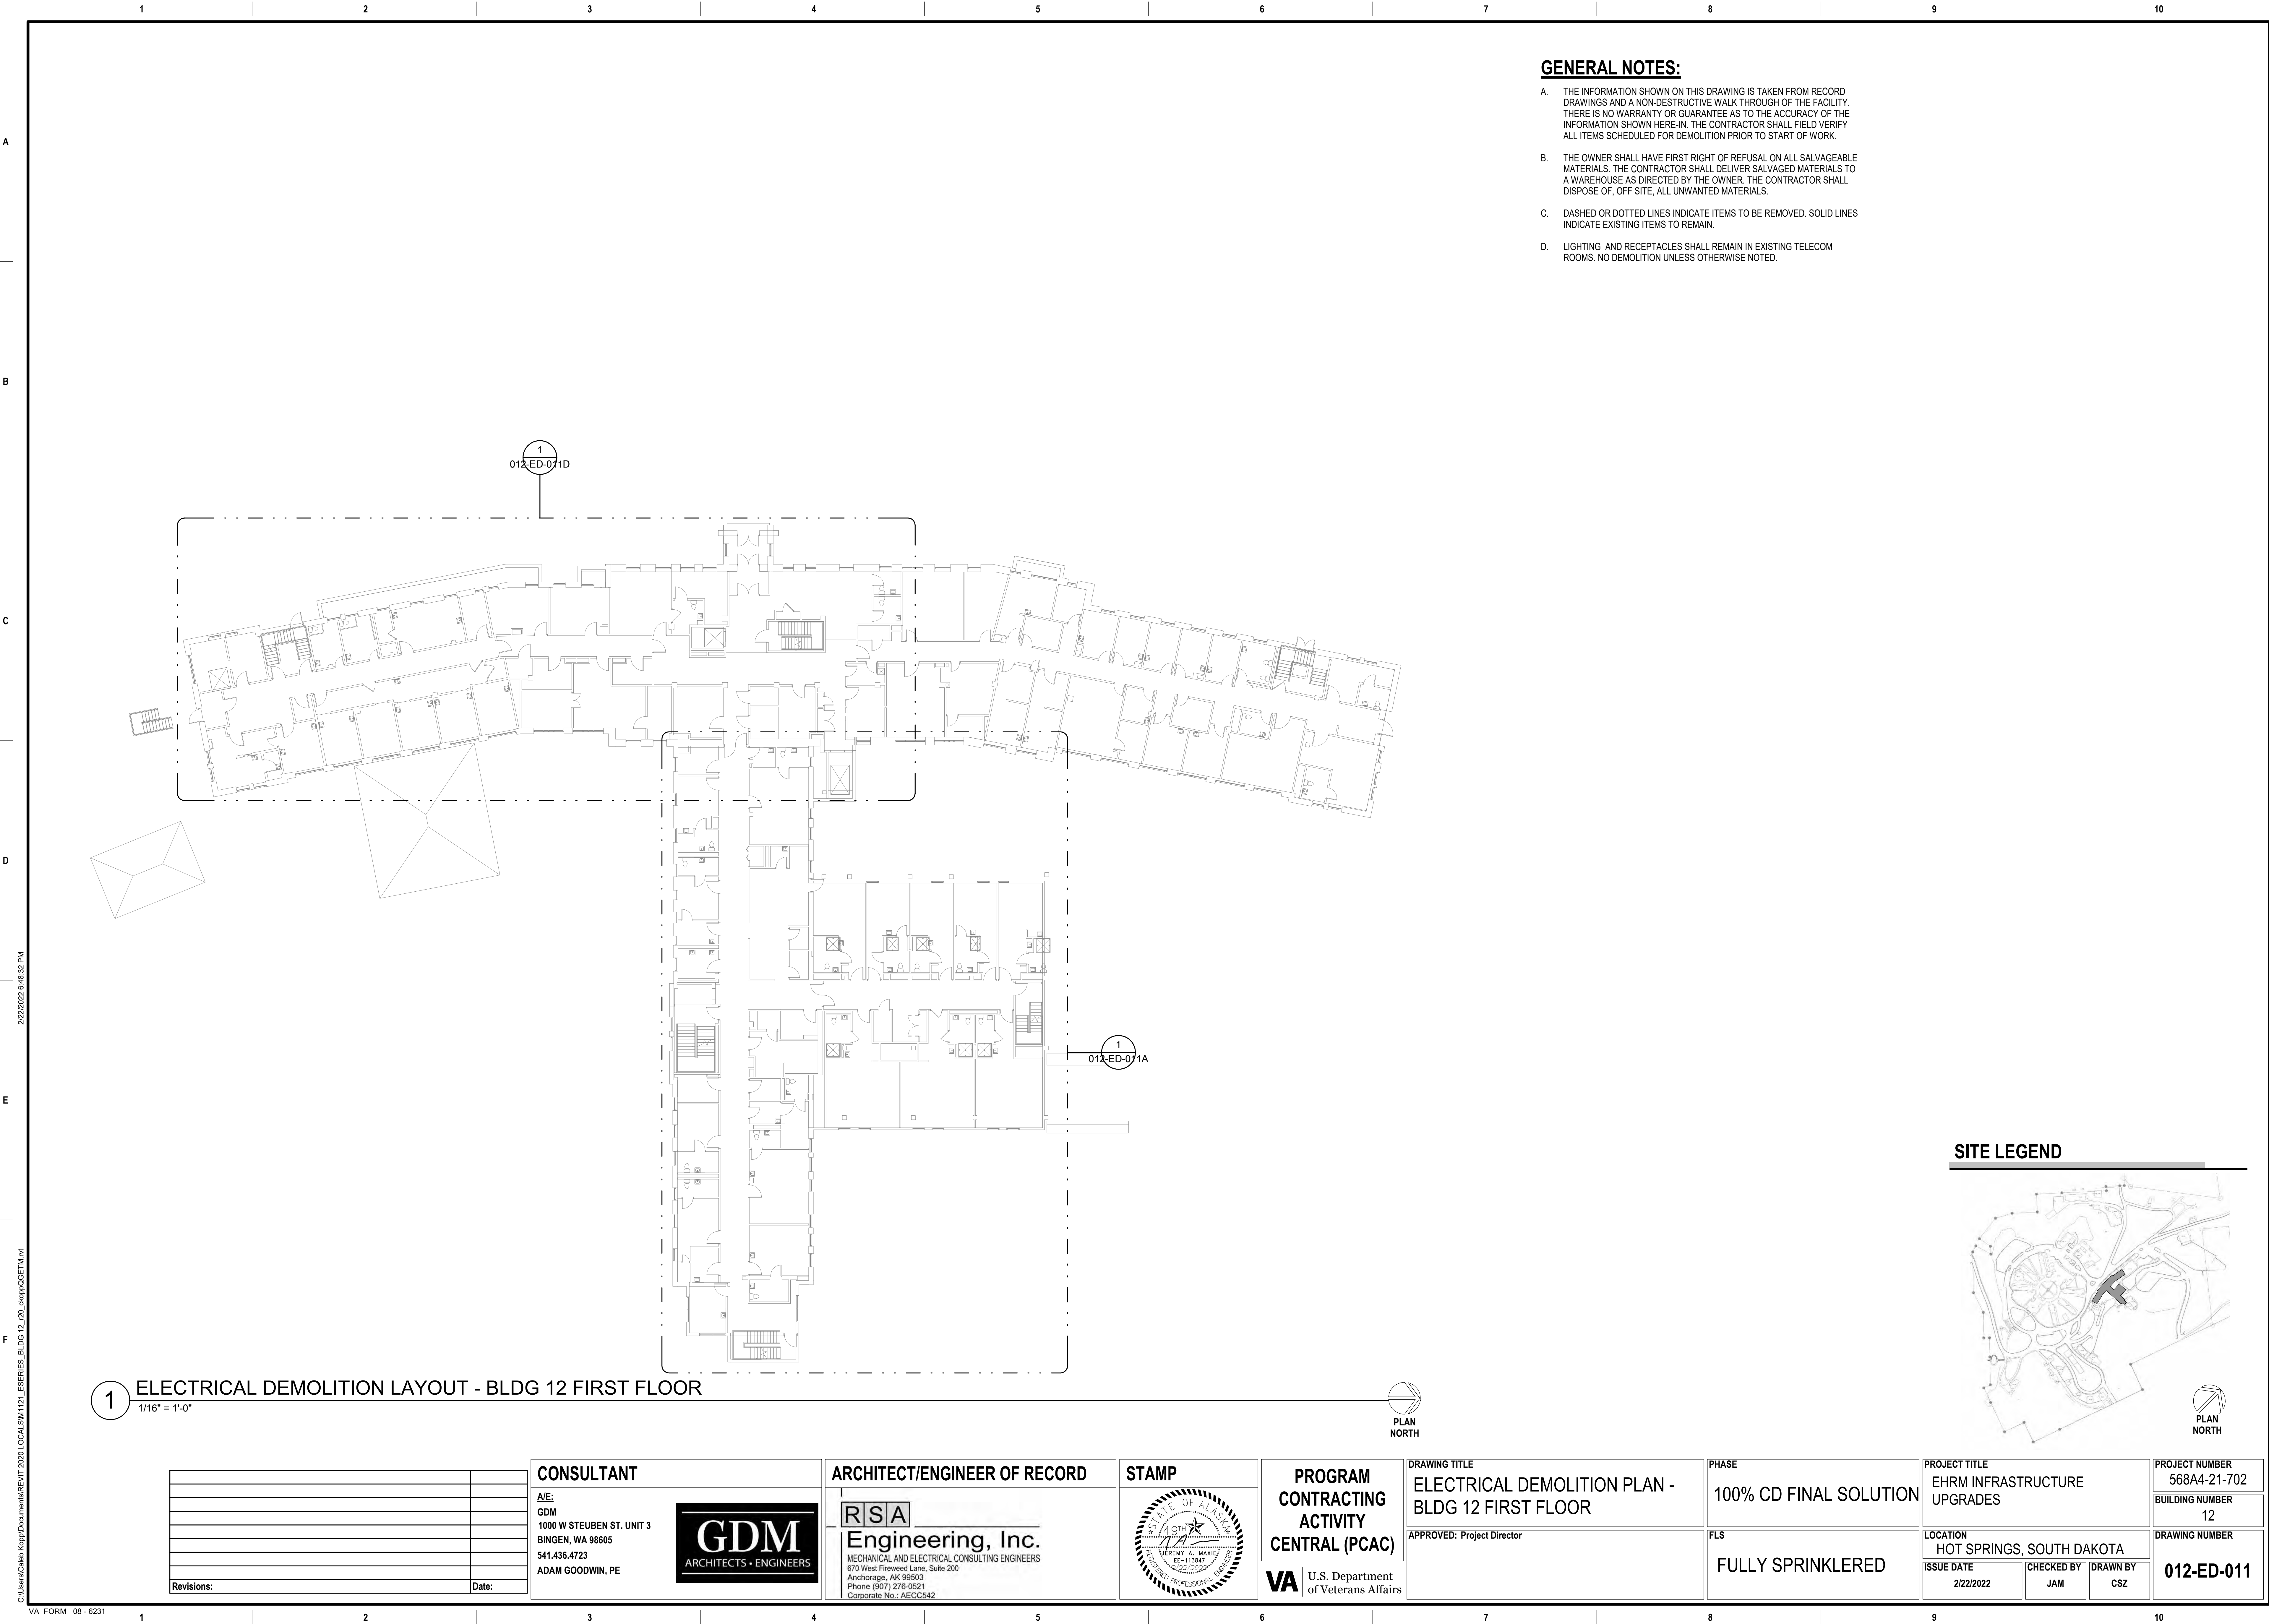

GENERAL NOTES:

- A. THE INFORMATION SHOWN ON THIS DRAWING IS TAKEN FROM RECORD DRAWINGS AND A NON-DESTRUCTIVE WALK THROUGH OF THE FACILITY. THERE IS NO WARRANTY OR GUARANTEE AS TO THE ACCURACY OF THE INFORMATION SHOWN HERE-IN. THE CONTRACTOR SHALL FIELD VERIFY ALL ITEMS SCHEDULED FOR DEMOLITION PRIOR TO START OF WORK.
- B. THE OWNER SHALL HAVE FIRST RIGHT OF REFUSAL ON ALL SALVAGEABLE MATERIALS. THE CONTRACTOR SHALL DELIVER SALVAGED MATERIALS TO A WAREHOUSE AS DIRECTED BY THE OWNER. THE CONTRACTOR SHALL DISPOSE OF, OFF SITE, ALL UNWANTED MATERIALS.
- C. DASHED OR DOTTED LINES INDICATE ITEMS TO BE REMOVED. SOLID LINES INDICATE EXISTING ITEMS TO REMAIN.
- D. LIGHTING AND RECEPTACLES SHALL REMAIN IN EXISTING TELECOM ROOMS. NO DEMOLITION UNLESS OTHERWISE NOTED.

SITE LEGEND

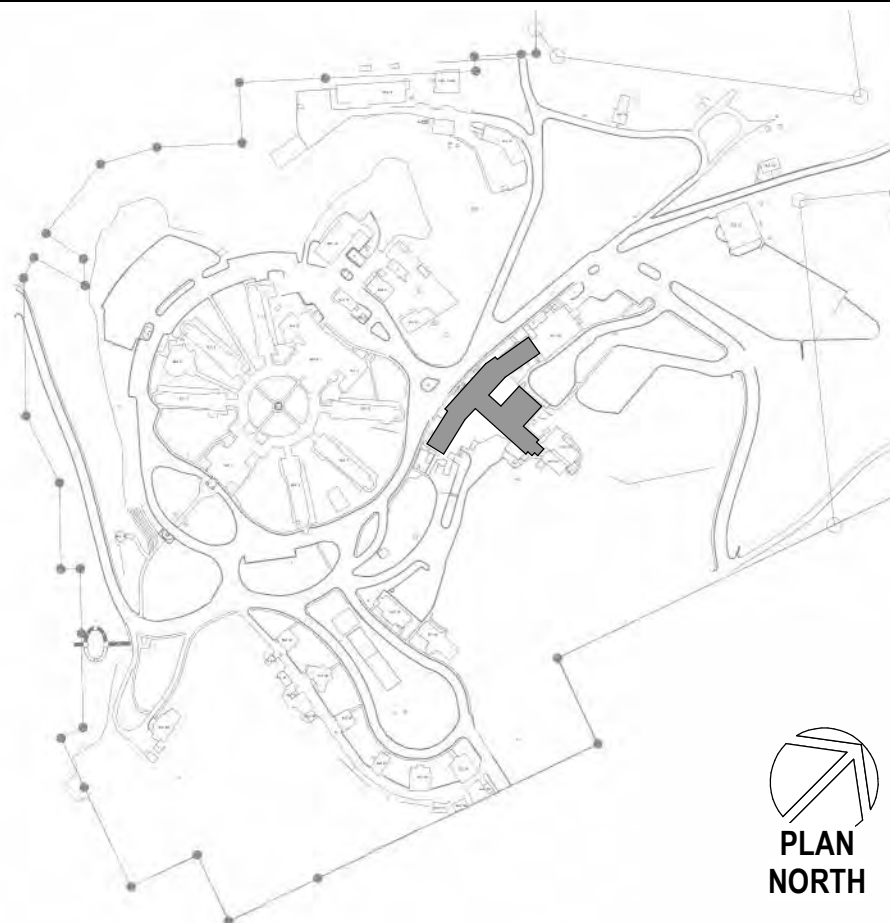

Revisions:	Date:

CONSULTANT

A/E:
GDM
1000 W STEUBEN ST. UNIT 3
BINGEN, WA 98605
541.436.4723
ADAM GOODWIN, PE

GDM
ARCHITECTS • ENGINEERS

ARCHITECT/ENGINEER OF RECORD

RSA
Engineering, Inc.
MECHANICAL AND ELECTRICAL CONSULTING ENGINEERS
670 West Firwood Lane, Suite 200
Anchorage, AK 99503
Phone (907) 276-0521
Corporate No.: AECC542

STAMP

STATE OF ALASKA
JEREMY A. MAXIE
ELECTRICAL ENGINEER
7747
2022-2025
REGISTERED PROFESSIONAL ENGINEER

PROGRAM CONTRACTING ACTIVITY CENTRAL (PCAC)

VA U.S. Department of Veterans Affairs

DRAWING TITLE
ELECTRICAL DEMOLITION PLAN - BLDG 12 FIRST FLOOR

APPROVED: Project Director

PHASE
100% CD FINAL SOLUTION

FLS
FULLY SPRINKLERED

PROJECT TITLE
EHRM INFRASTRUCTURE UPGRADES

LOCATION
HOT SPRINGS, SOUTH DAKOTA

ISSUE DATE
2/22/2022

CHECKED BY
JAM

DRAWN BY
CSZ

PROJECT NUMBER
568A4-21-702

BUILDING NUMBER
12

DRAWING NUMBER
012-ED-011

A

B

C

D

E

F

A


B

C

D

E

F

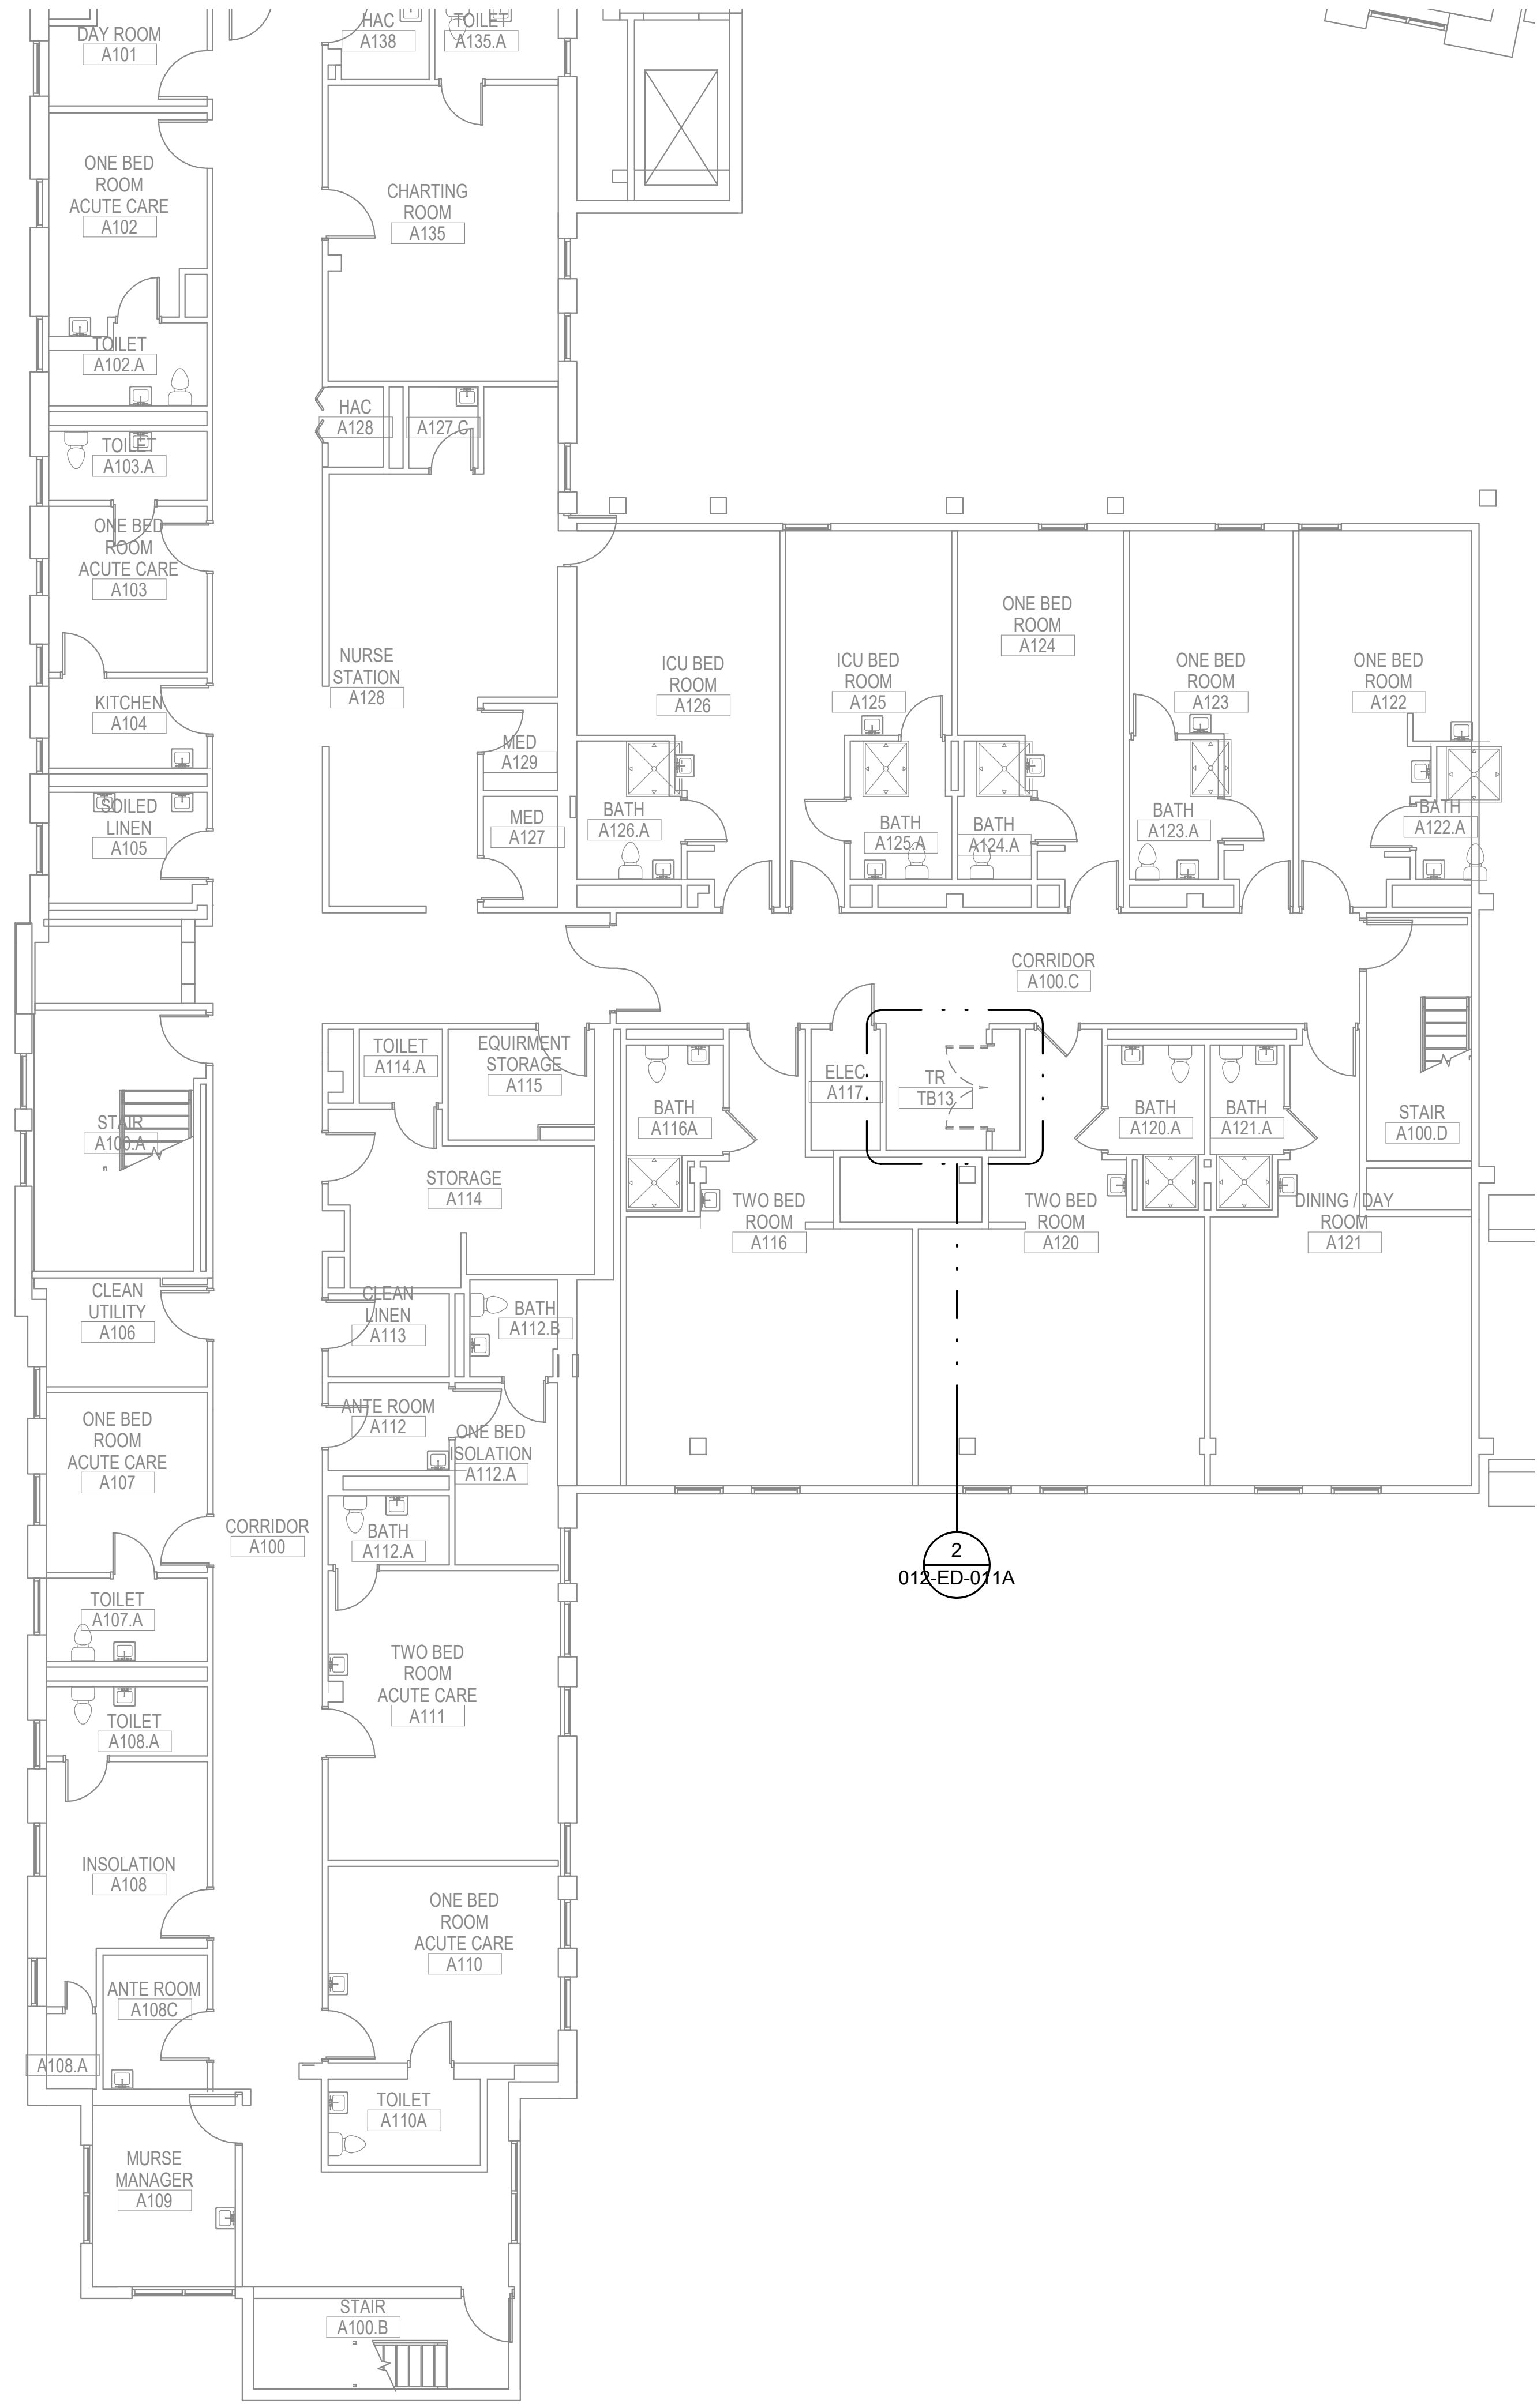


1 ELECTRICAL DEMOLITION PLAN - BLDG 12 FIRST FLOOR SECTOR A
1/8" = 1'-0"

GENERAL NOTES:

A. SEE SHEET 012-ED-011 FOR GENERAL NOTES.


SHEET NOTES:

1. DEMOLISH SWITCHES, LIGHTING, AND RECEPTACLES IN ROOM. DEMOLISH CIRCUITS TO UPSTREAM JUNCTION BOX TO ALLOW FOR NEW CIRCUITING.

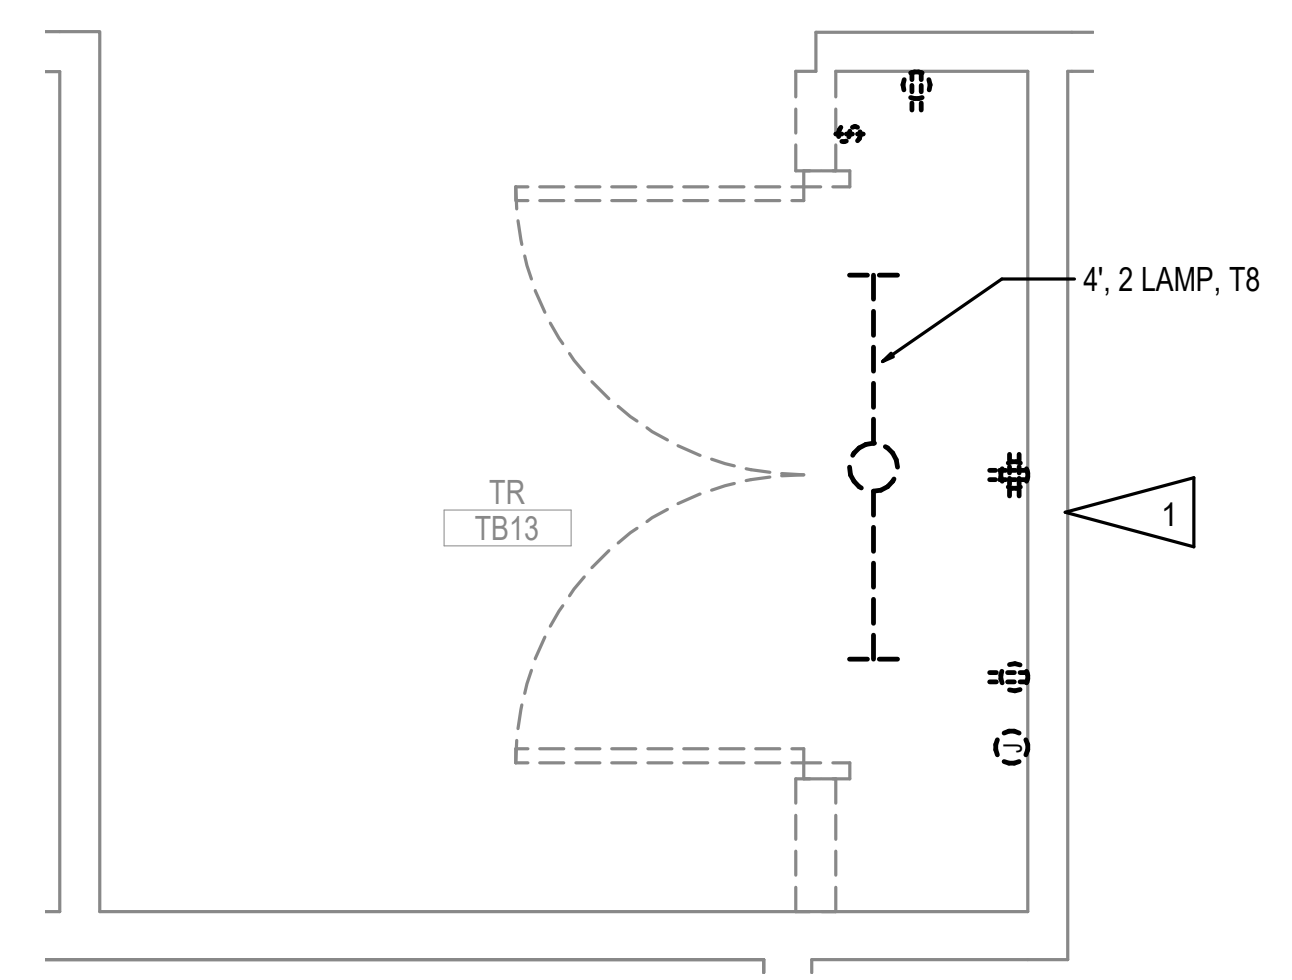

2 ENLARGED ROOM - A119 ELECTRICAL DEMOLITION
1/2" = 1'-0"

SITE LEGEND

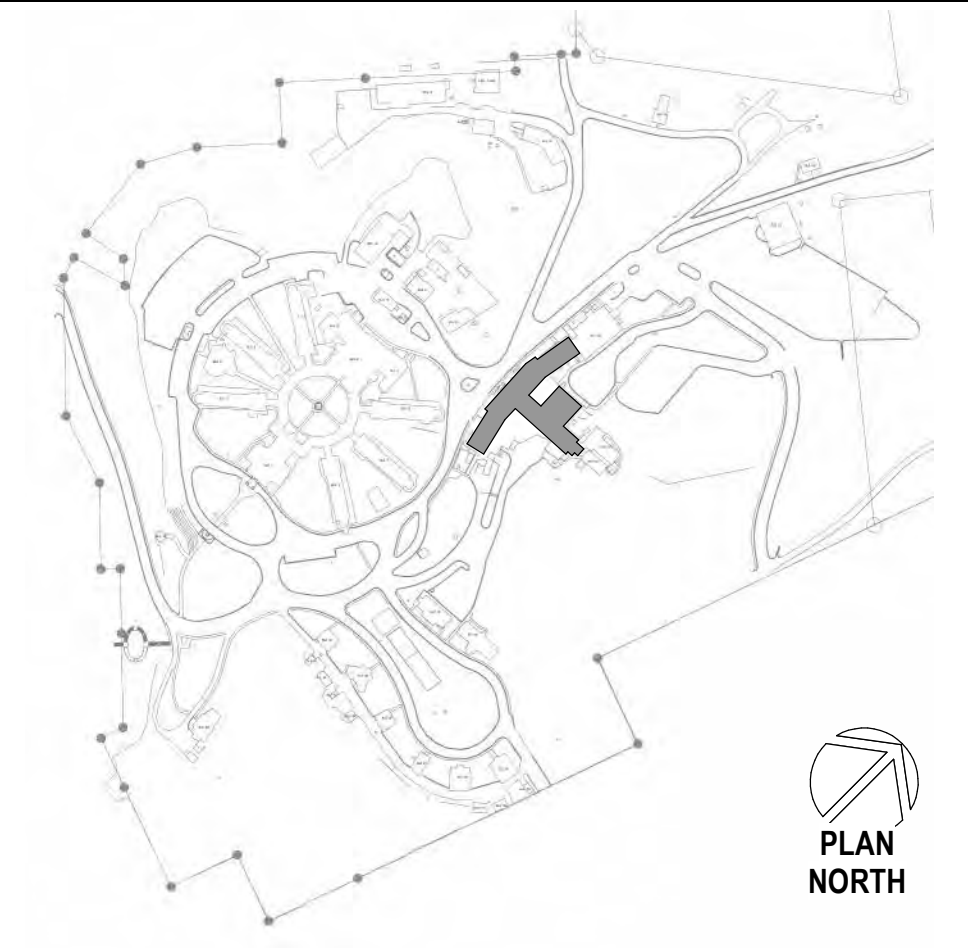

C:\Users\Caleb\AppData\Local\Microsoft\Windows\Temporary Internet Files\Content.IE5\B3QJ6T\012-ED-011A.dwg

A

B

C

D

E

F

A

B

C

D

E


F

GENERAL NOTES:


A. SEE SHEET 012-ED-011 FOR GENERAL NOTES.


SHEET NOTES:

1. DEMOLISH SWITCHES, LIGHTING, AND RECEPTACLES IN ROOM. DEMOLISH CIRCUITS TO UPSTREAM JUNCTION BOX TO ALLOW FOR NEW CIRCUITING.

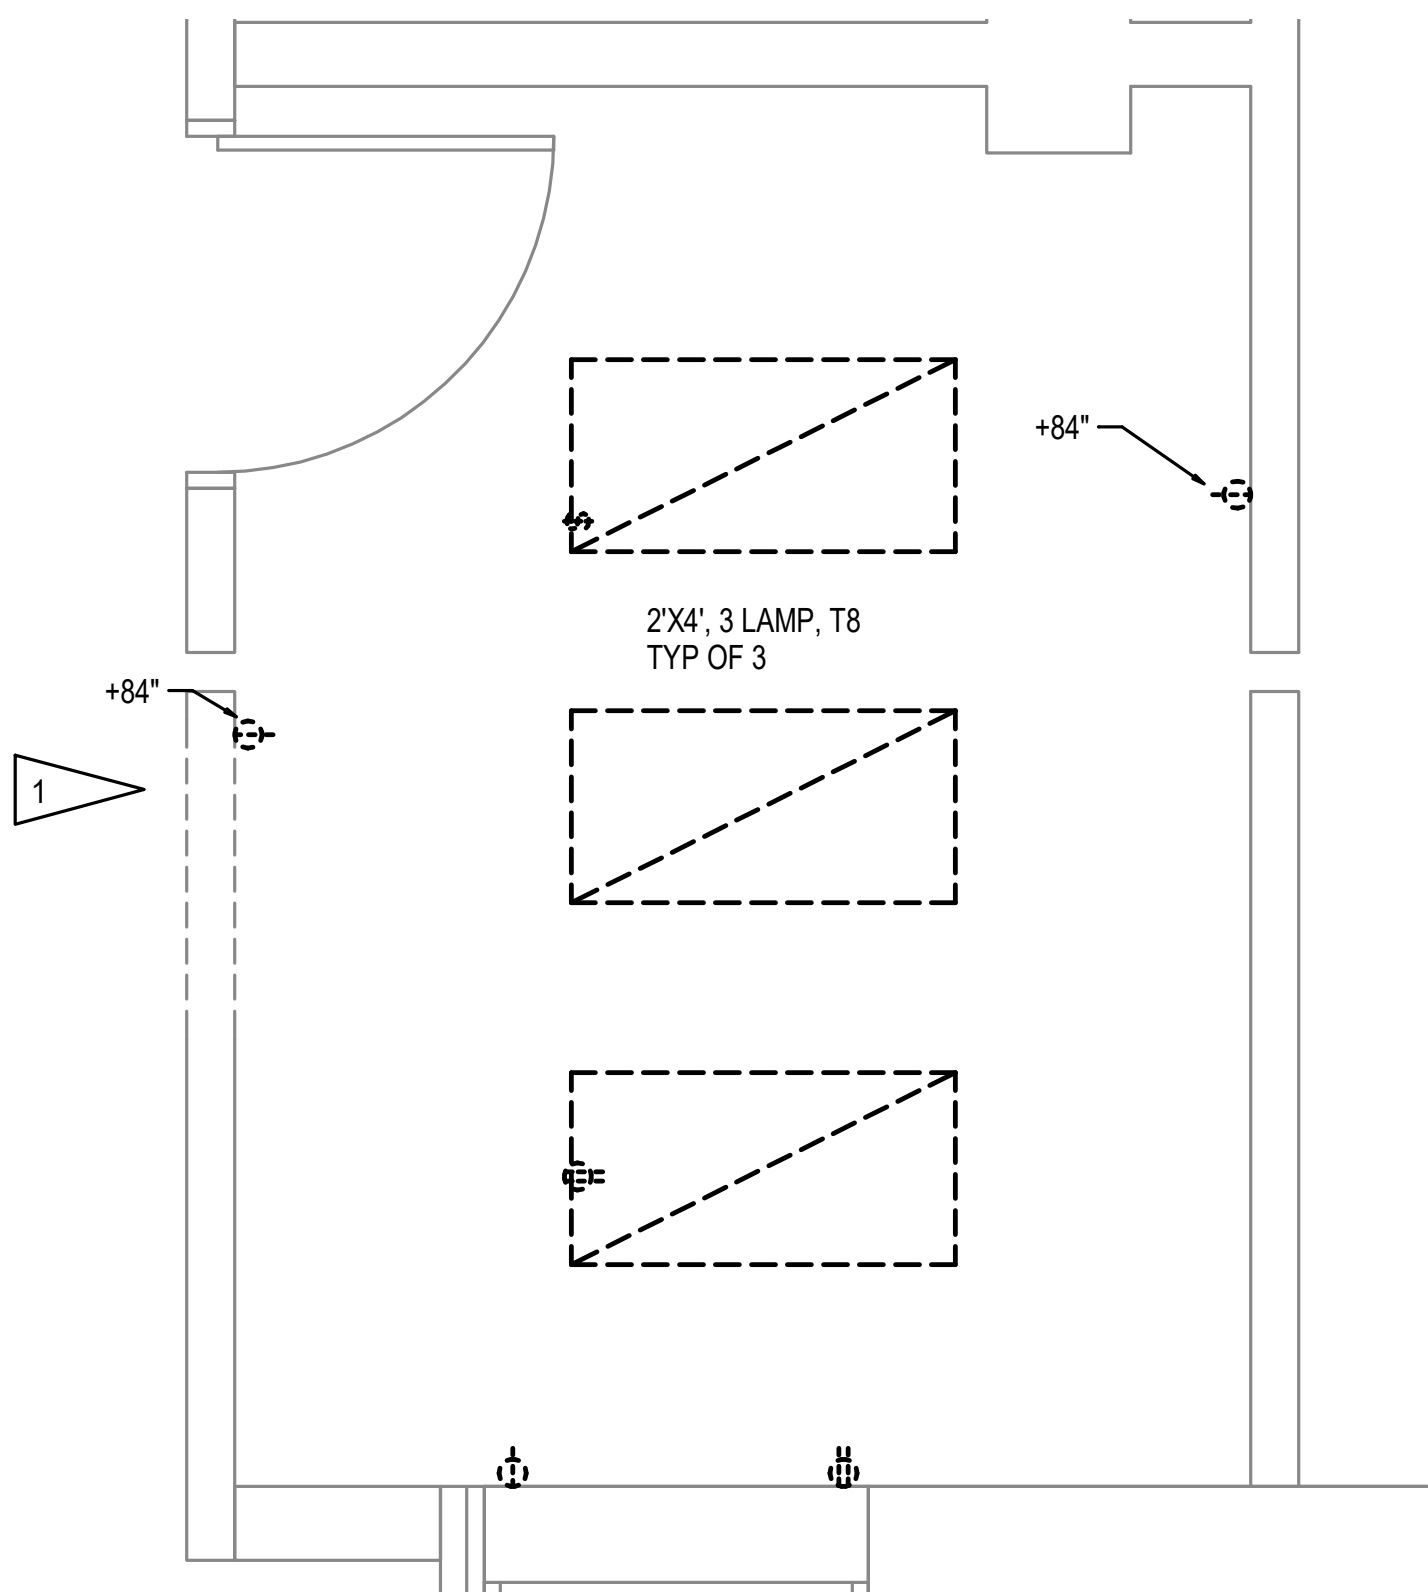

2 ENLARGED ROOM - C105 ELECTRICAL DEMOLITION
1/2" = 1'-0"

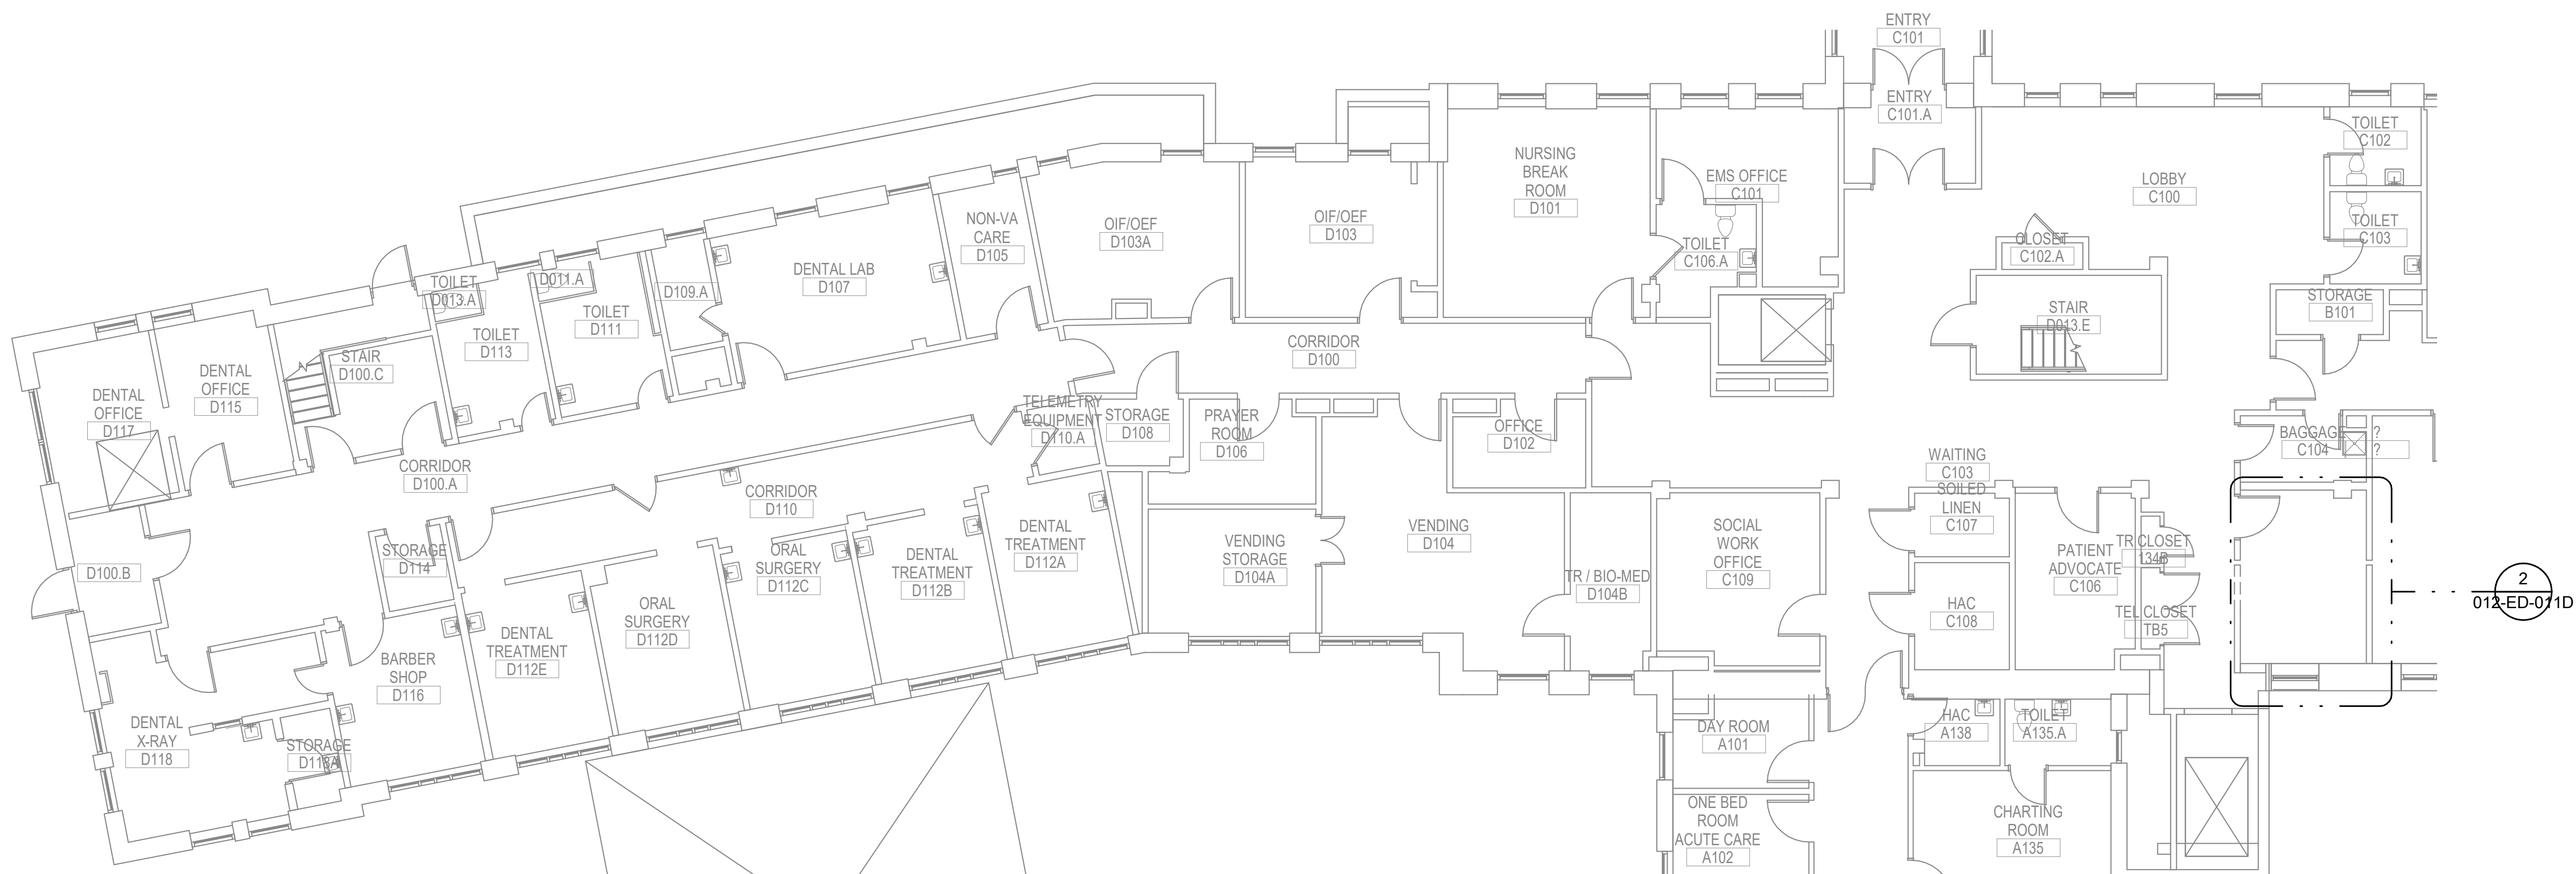

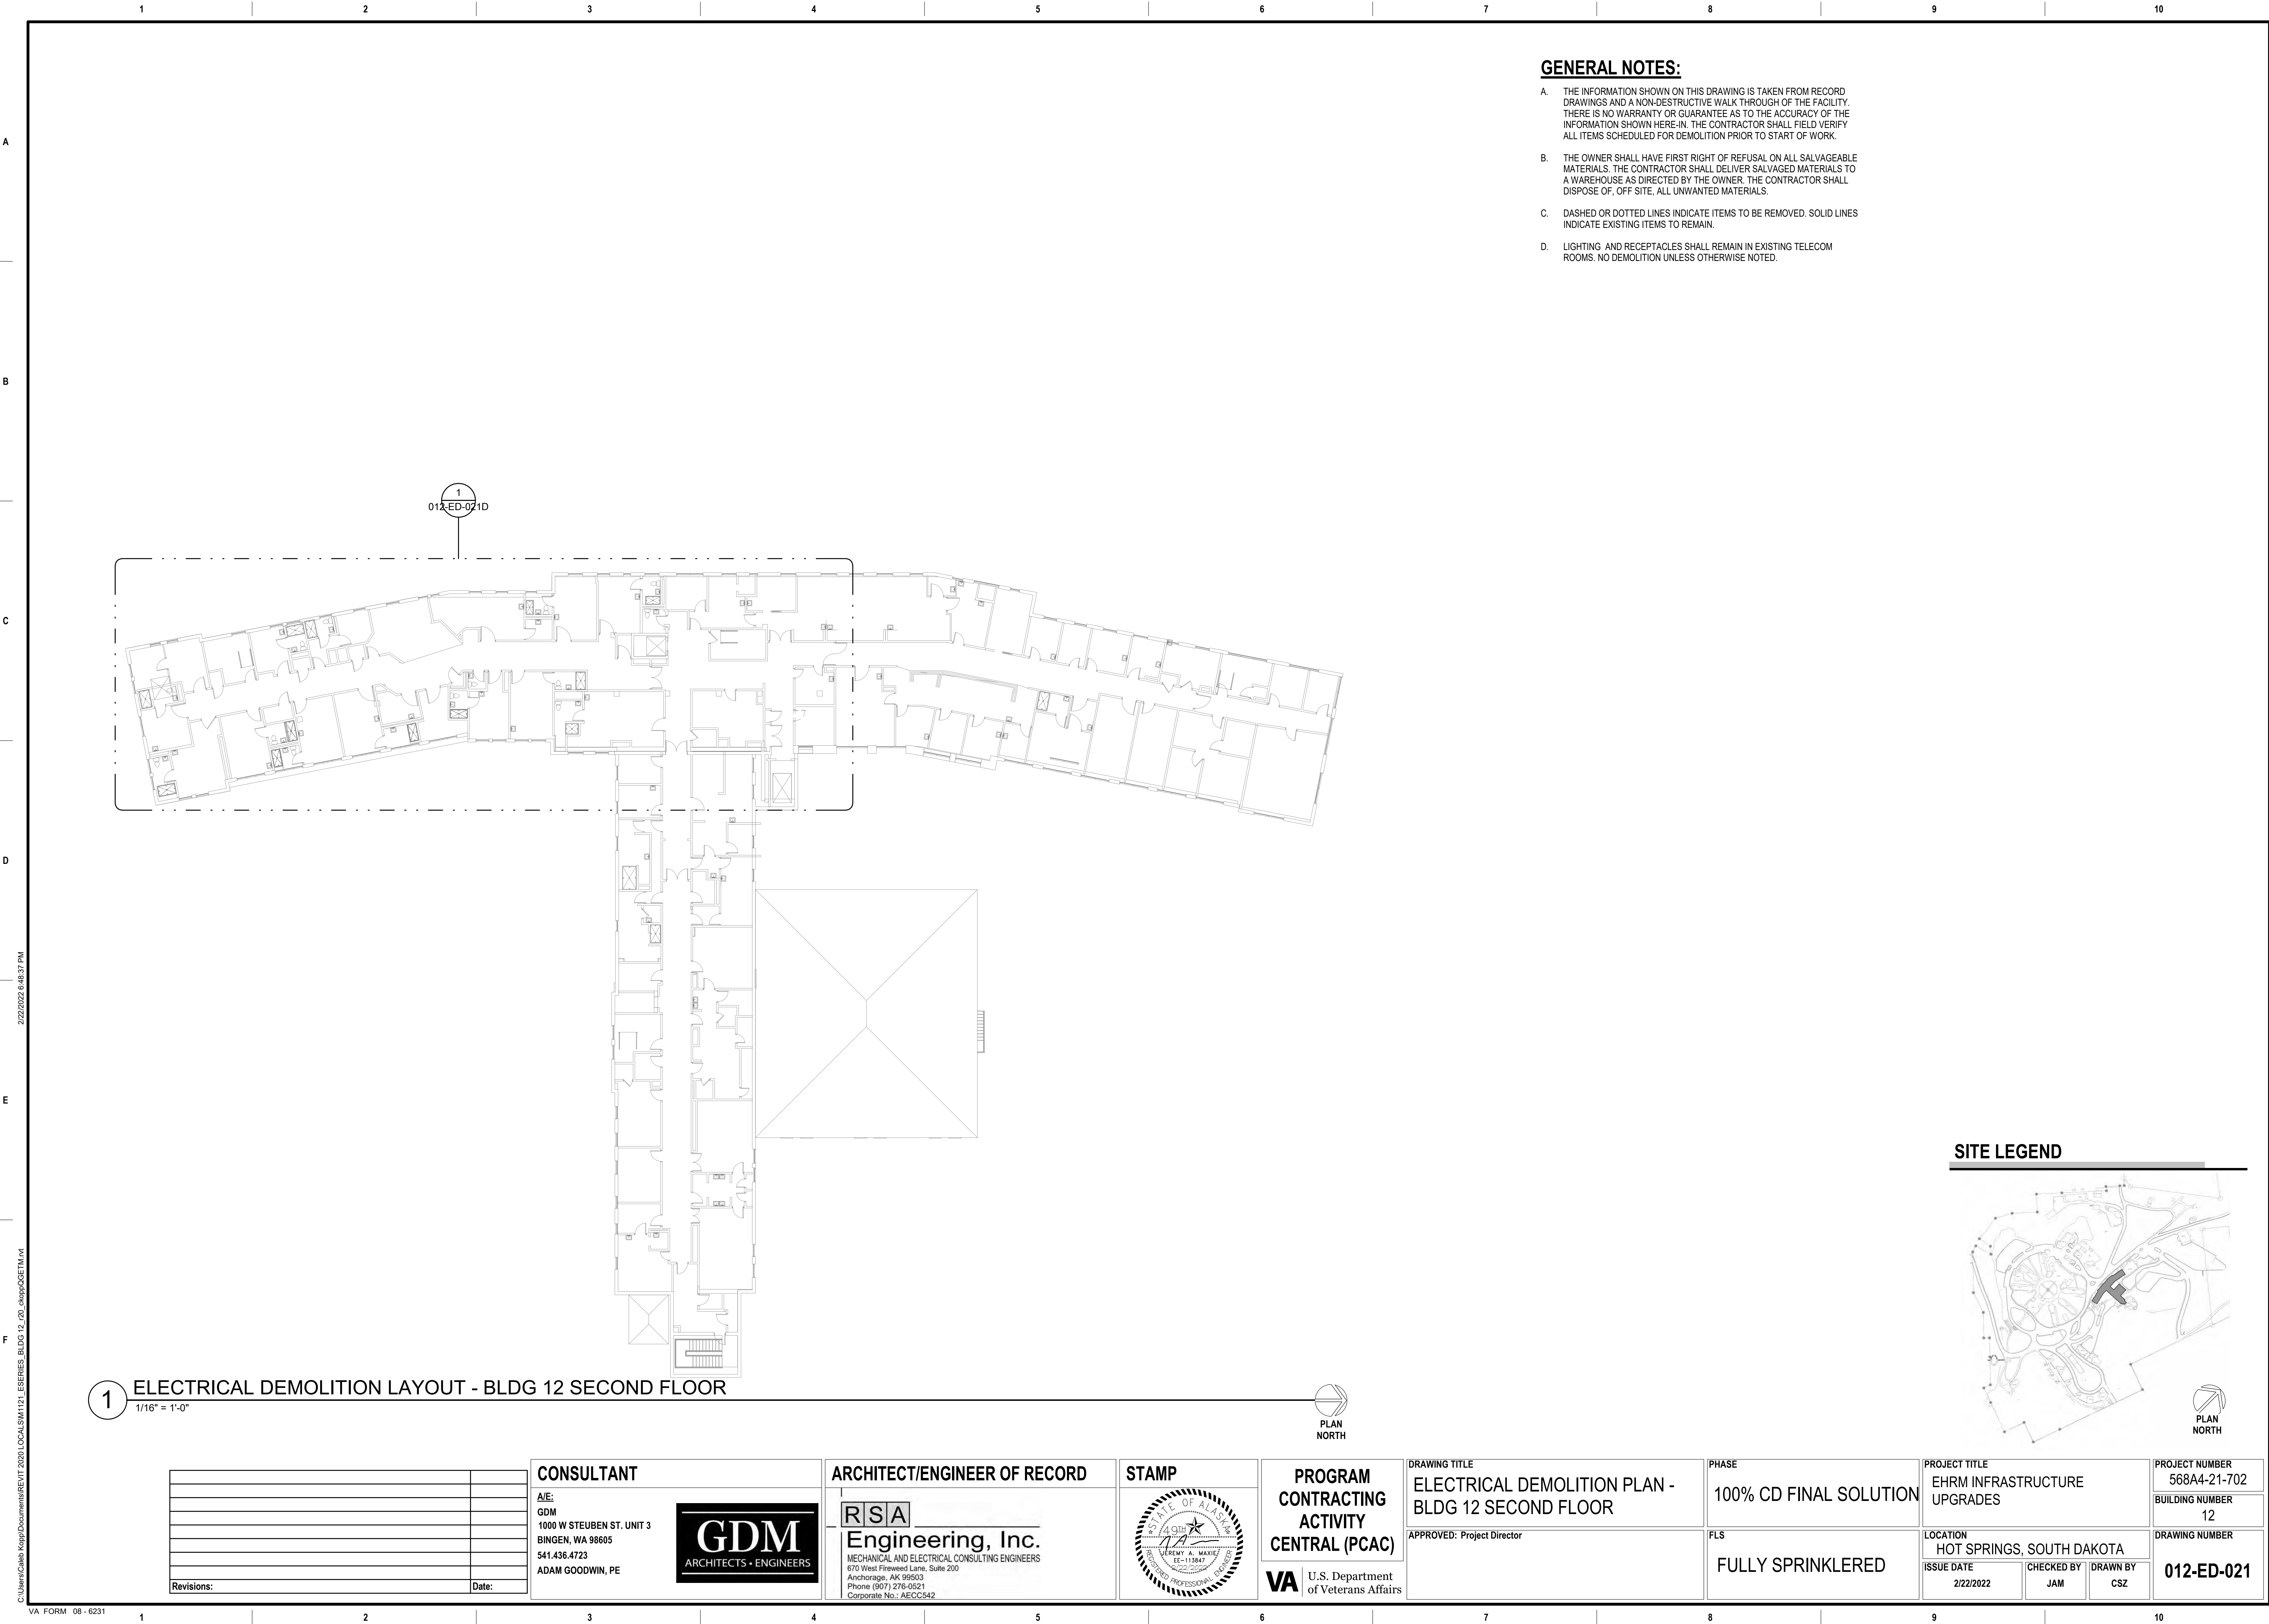

A

B

C

D

E

F

A

B

C

D

E


F

GENERAL NOTES:

A. SEE SHEET 012-ED-021 FOR GENERAL NOTES.


SHEET NOTES:


1. DEMOLISH SWITCHES, LIGHTING, AND RECEPTACLES IN ROOM. DEMOLISH CIRCUITS TO UPSTREAM JUNCTION BOX TO ALLOW FOR NEW CIRCUITING.

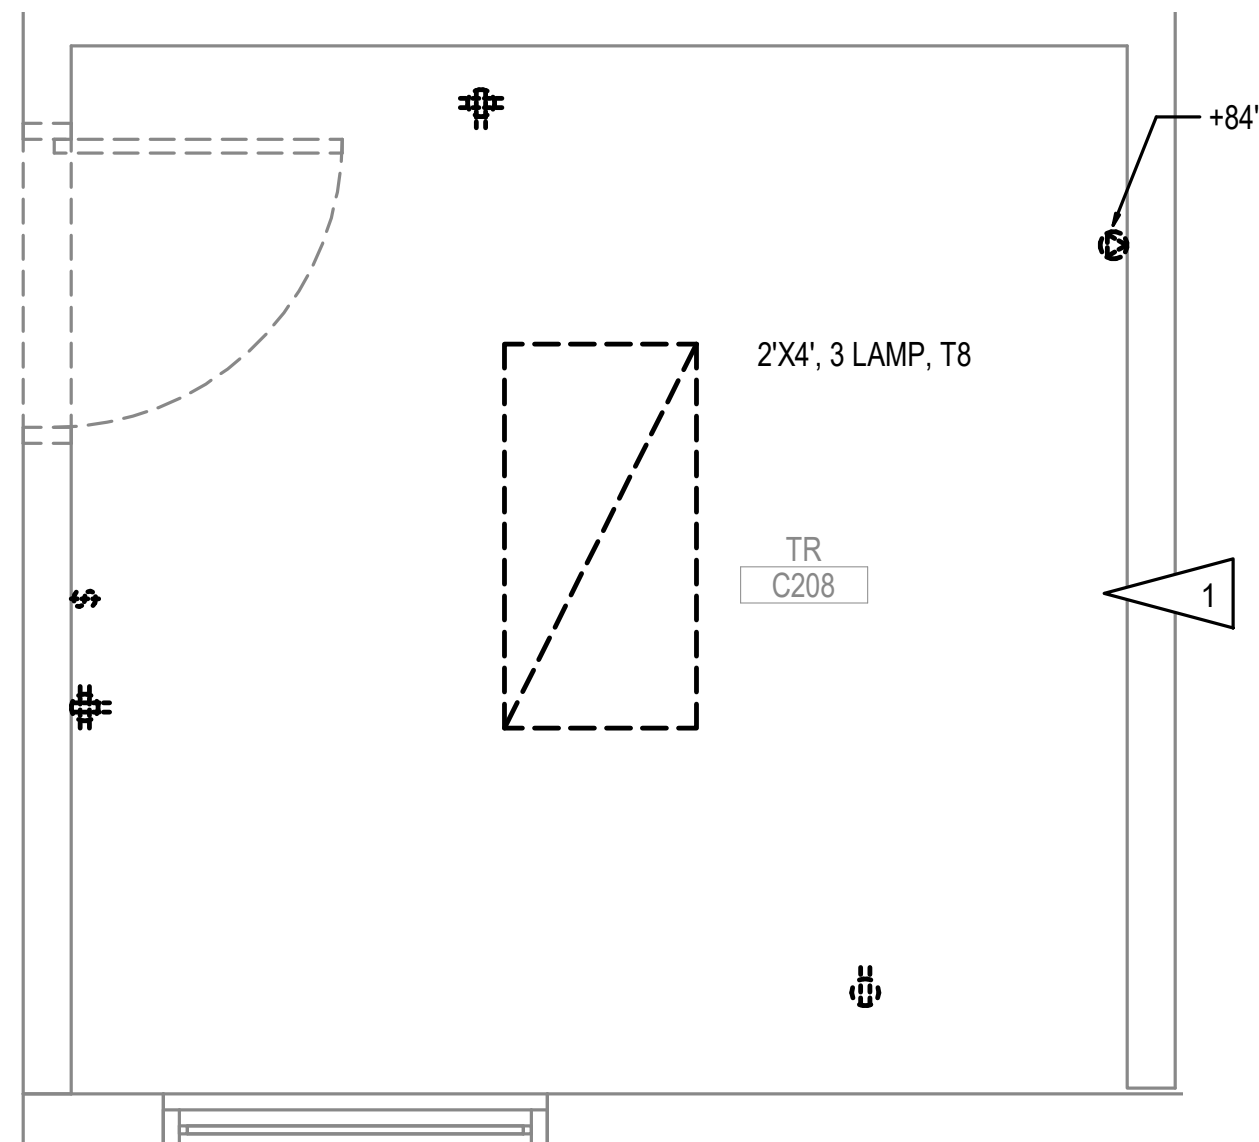

2 ENLARGED ROOM - C208 ELECTRICAL DEMOLITION

1/2" = 1'-0"

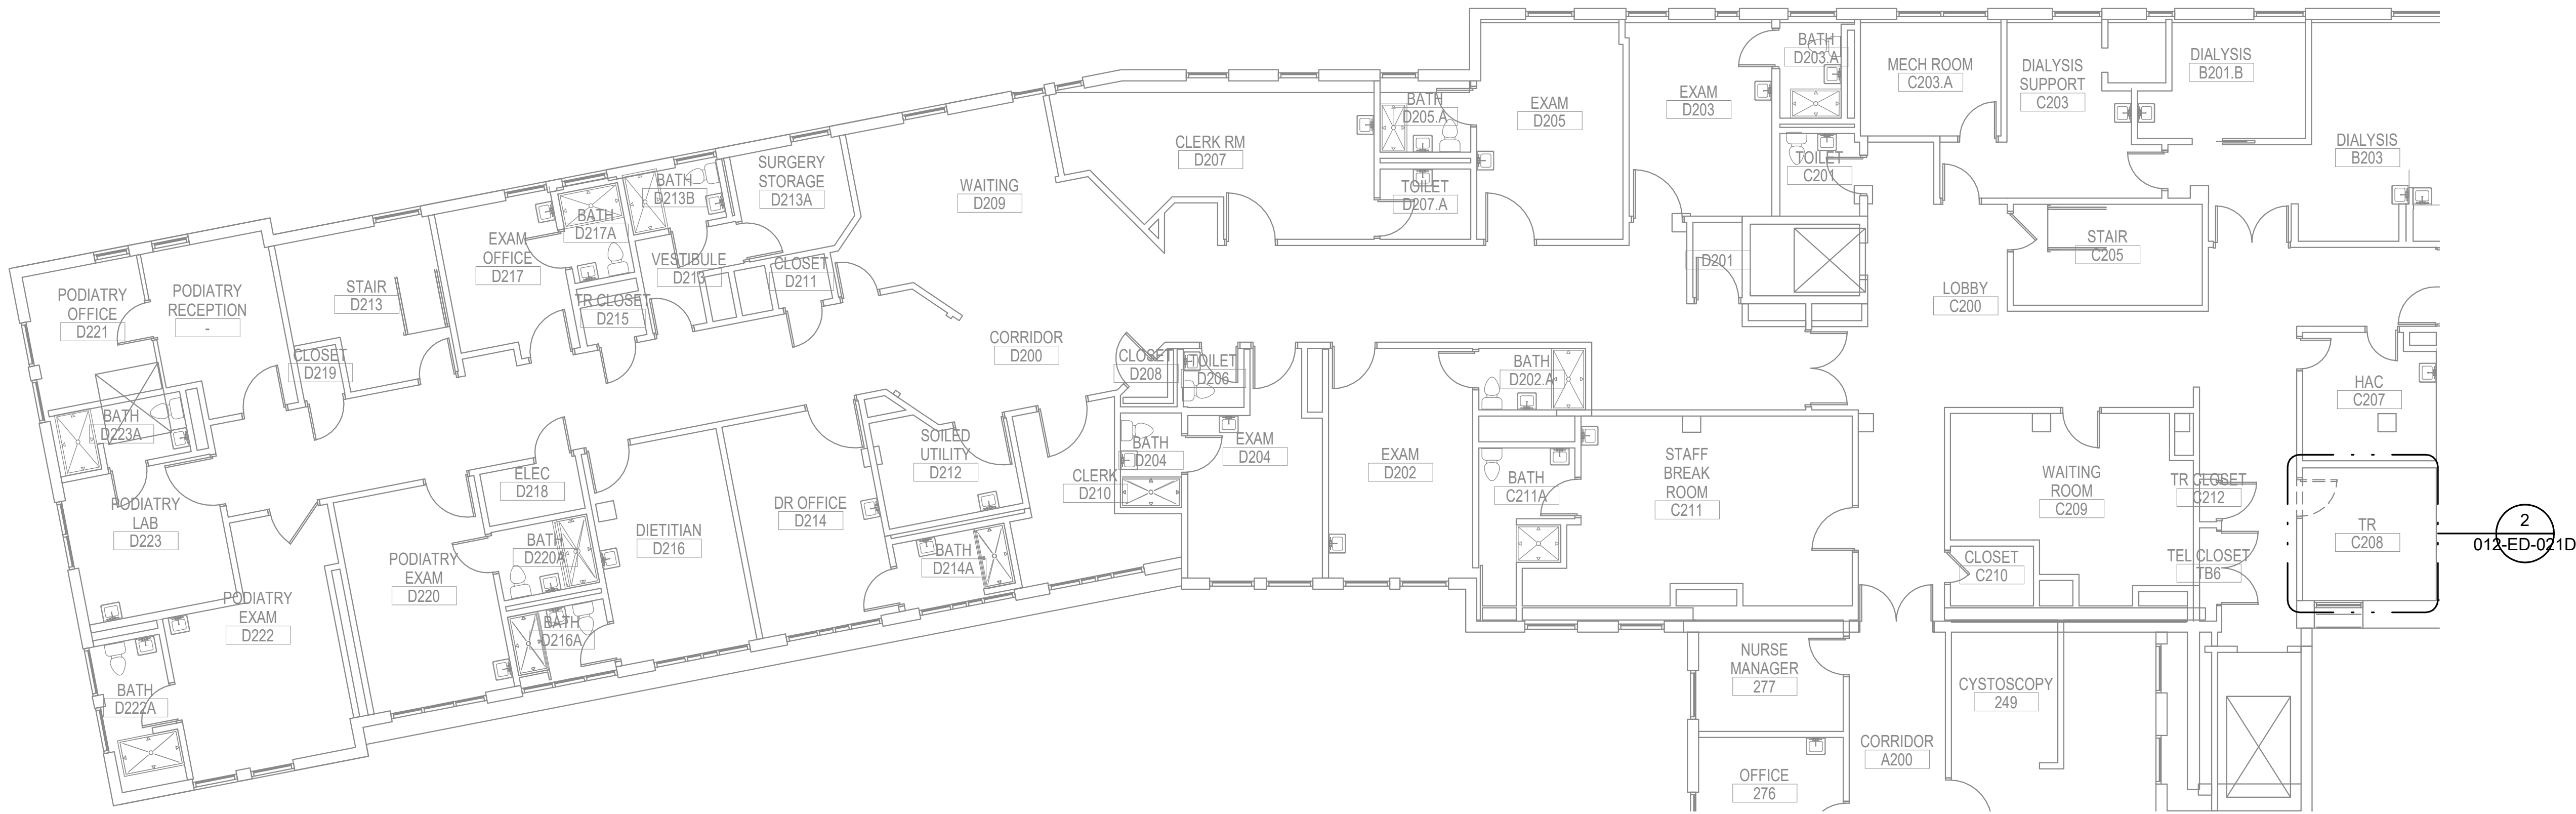


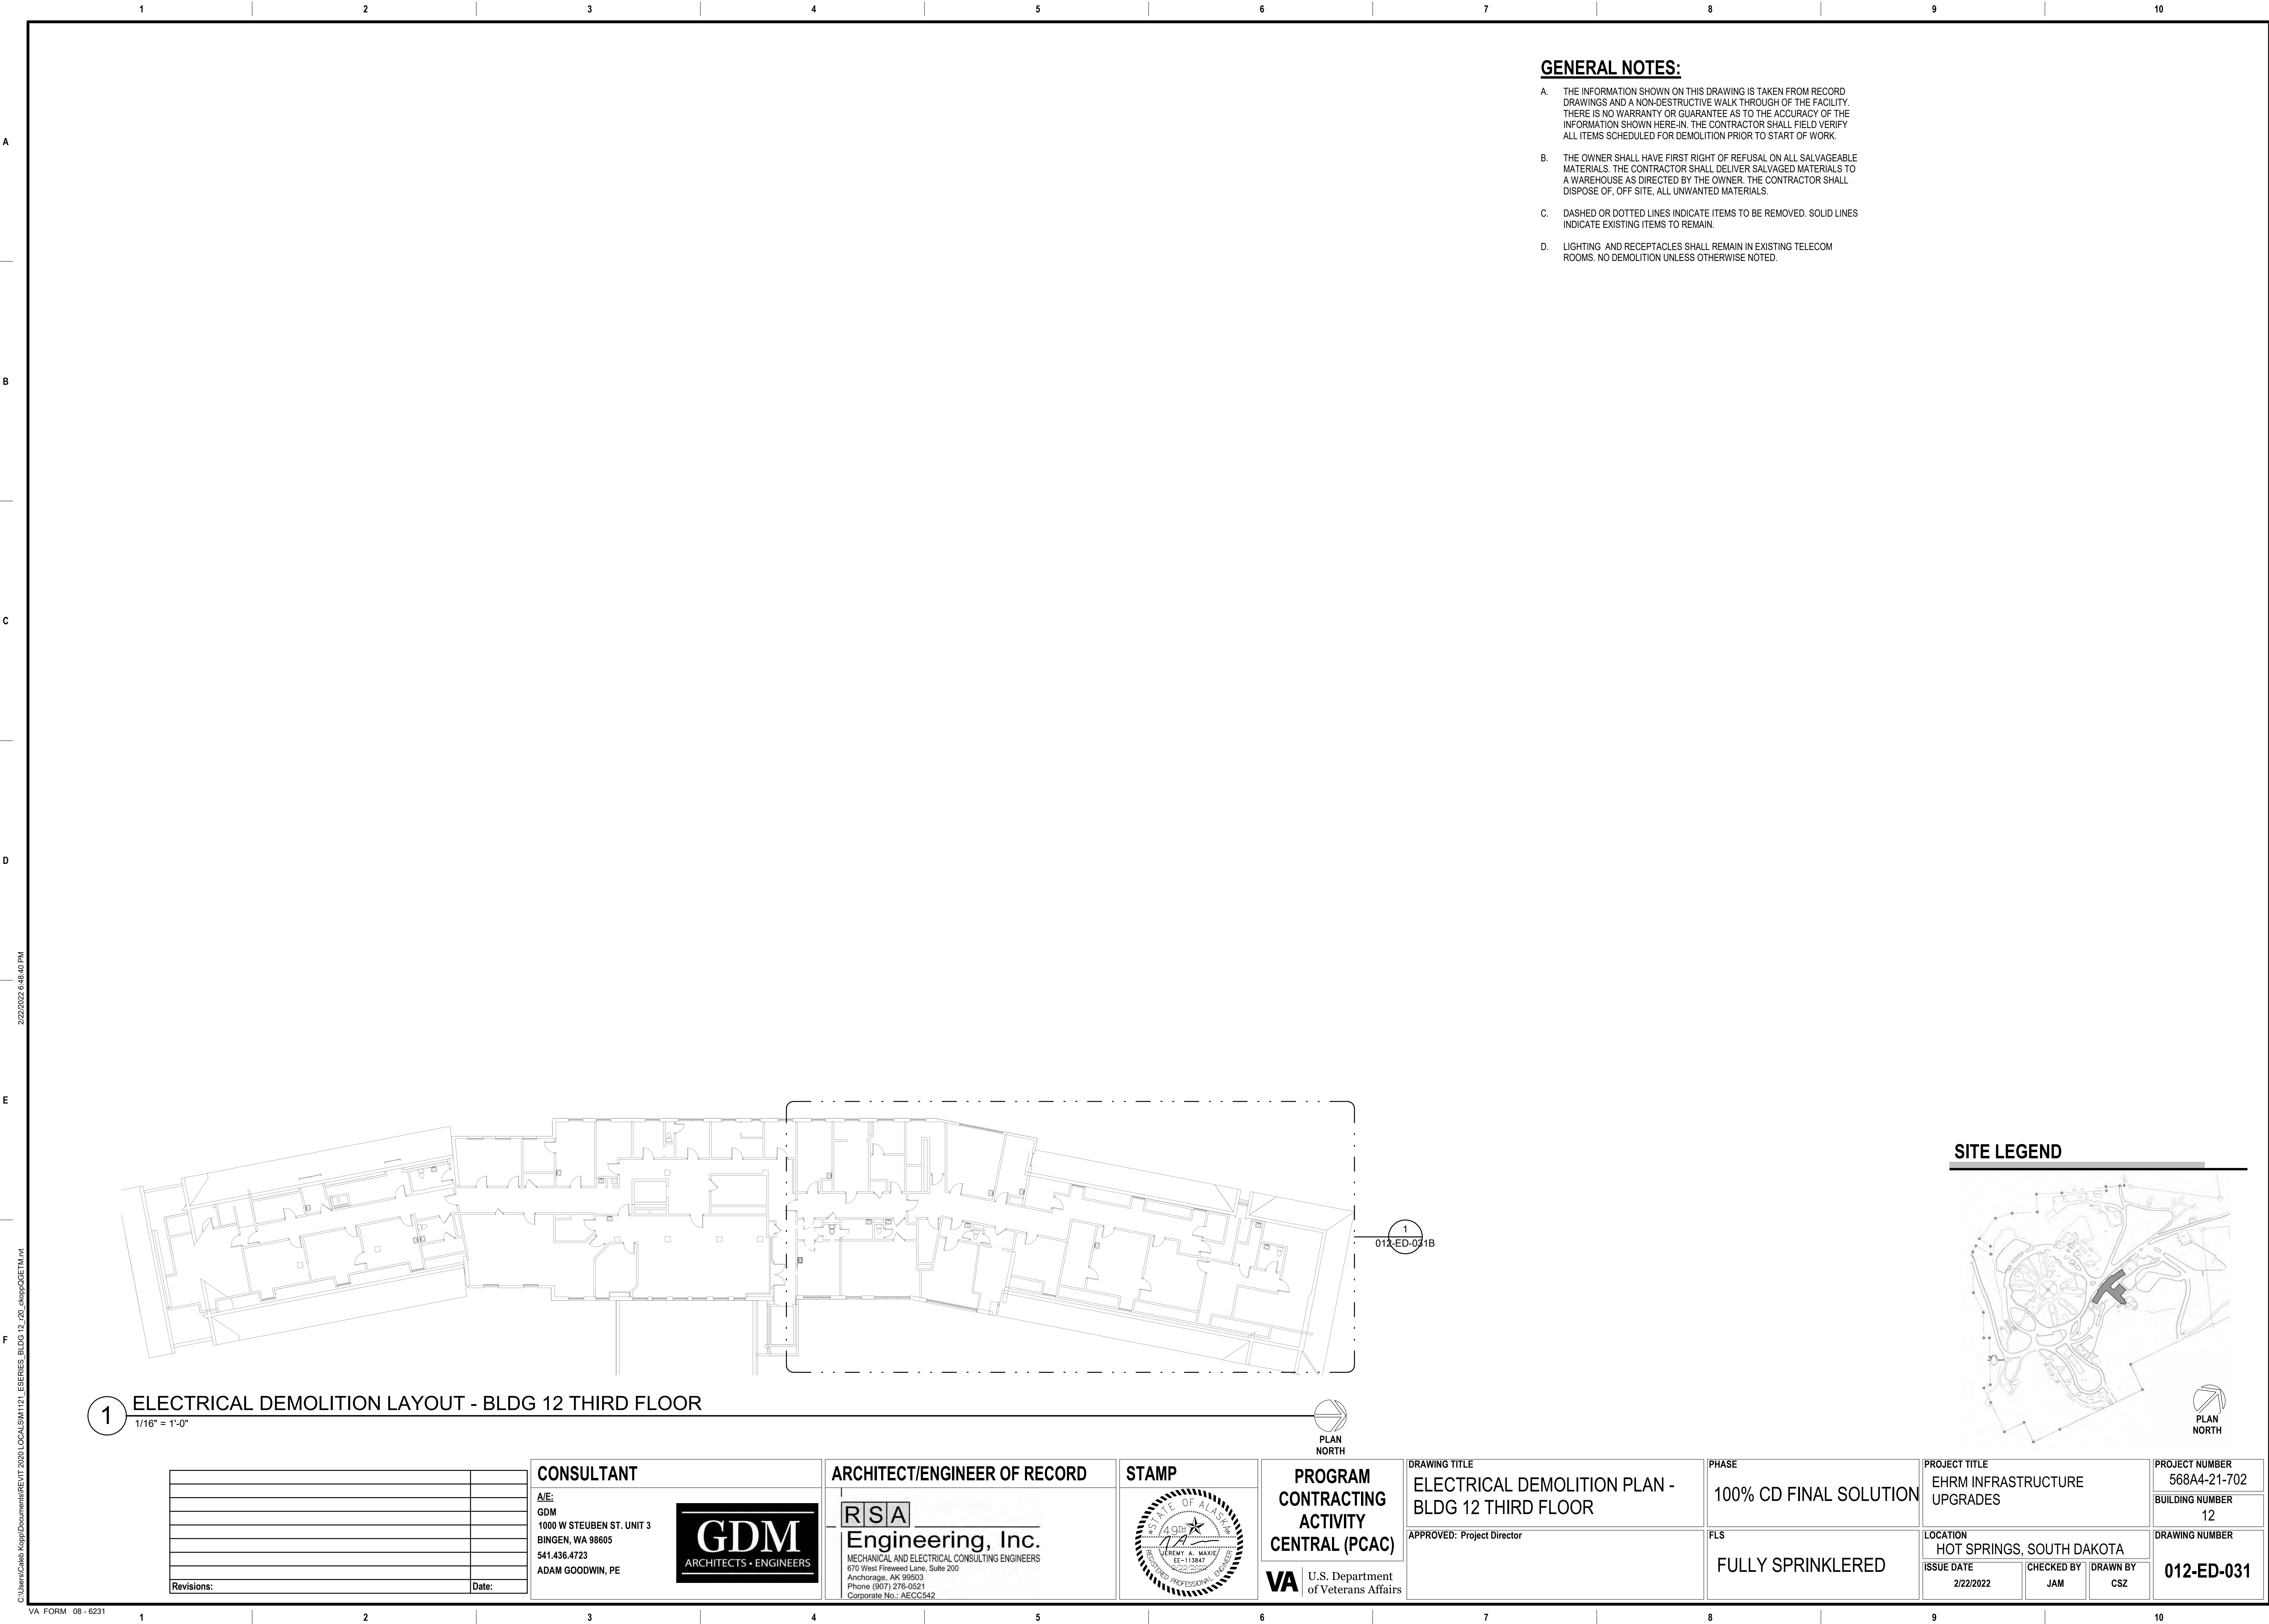

GENERAL NOTES:

- A. THE INFORMATION SHOWN ON THIS DRAWING IS TAKEN FROM RECORD DRAWINGS AND A NON-DESTRUCTIVE WALK THROUGH OF THE FACILITY. THERE IS NO WARRANTY OR GUARANTEE AS TO THE ACCURACY OF THE INFORMATION SHOWN HERE-IN. THE CONTRACTOR SHALL FIELD VERIFY ALL ITEMS SCHEDULED FOR DEMOLITION PRIOR TO START OF WORK.
- B. THE OWNER SHALL HAVE FIRST RIGHT OF REFUSAL ON ALL SALVAGEABLE MATERIALS. THE CONTRACTOR SHALL DELIVER SALVAGED MATERIALS TO A WAREHOUSE AS DIRECTED BY THE OWNER. THE CONTRACTOR SHALL DISPOSE OF, OFF SITE, ALL UNWANTED MATERIALS.
- C. DASHED OR DOTTED LINES INDICATE ITEMS TO BE REMOVED. SOLID LINES INDICATE EXISTING ITEMS TO REMAIN.
- D. LIGHTING AND RECEPTACLES SHALL REMAIN IN EXISTING TELECOM ROOMS. NO DEMOLITION UNLESS OTHERWISE NOTED.


SITE LEGEND

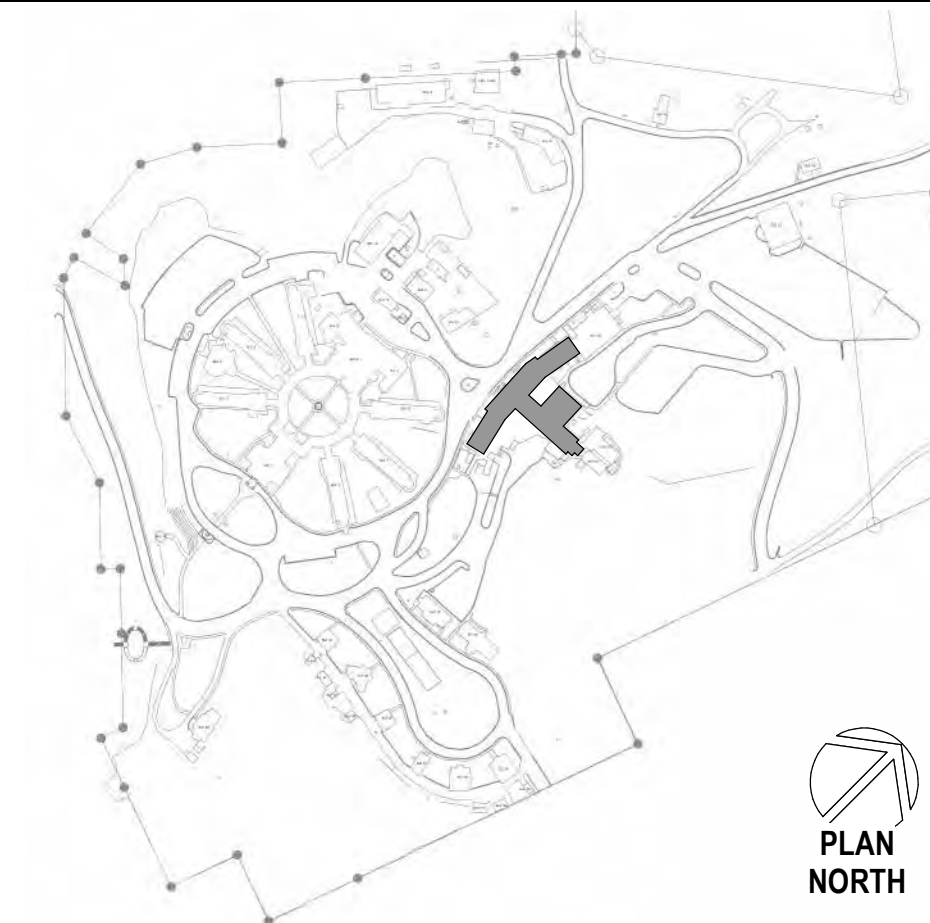



1/2" = 1'-0"

1/2" = 1'-0"

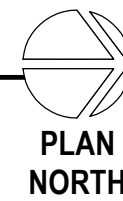

1/8" = 1'-0"

1/8" = 1'-0"

CONSULTANT

A/E:
GDM
1000 W STEUBEN ST. UNIT 3
BINGEN, WA 98605
541.436.4723
ADAM GOODWIN, PE

GDM
ARCHITECTS - ENGINEERS

RSA
Engineering, Inc.
MECHANICAL AND ELECTRICAL CONSULTING ENGINEERS
670 West Fireweed Lane, Suite 200
Anchorage, AK 99503
Phone (907) 276-0521
Corporate No.: AECC542

VA | U.S. Department
of Veterans Affairs

APPROVED: Project Director

FULLY SPRINKLERED

CHECKED BY

1	2	3	466
---	---	---	---	---	---	---	---	---	----	----	-----	-----	

PLAN NORTH





PLAN
NORTH

- A. THE INFORMATION SHOWN ON THIS DRAWING IS TAKEN FROM RECORD DRAWINGS AND A NON-DESTRUCTIVE WALK THROUGH OF THE FACILITY. THERE IS NO WARRANTY OR GUARANTEE AS TO THE ACCURACY OF THE INFORMATION SHOWN HERE-IN. THE CONTRACTOR SHALL FIELD VERIFY ALL ITEMS SCHEDULED FOR DEMOLITION PRIOR TO START OF WORK.
- B. THE OWNER SHALL HAVE FIRST RIGHT OF REFUSAL ON ALL SALVAGEABLE MATERIALS. THE CONTRACTOR SHALL DELIVER SALVAGED MATERIALS TO A WAREHOUSE AS DIRECTED BY THE OWNER. THE CONTRACTOR SHALL DISPOSE OF, OFF SITE, ALL UNWANTED MATERIALS.
- C. DASHED OR DOTTED LINES INDICATE ITEMS TO BE REMOVED. SOLID LINES INDICATE EXISTING ITEMS TO REMAIN.
- D. LIGHTING AND RECEPTACLES SHALL REMAIN IN EXISTING TELECOM ROOMS. NO DEMOLITION UNLESS OTHERWISE NOTED.


1. DEMOLISH SWITCHES, LIGHTING, AND RECEPTACLES IN ROOM. DEMOLISH CIRCUITS TO UPSTREAM JUNCTION BOX TO ALLOW FOR NEW CIRCUITING.

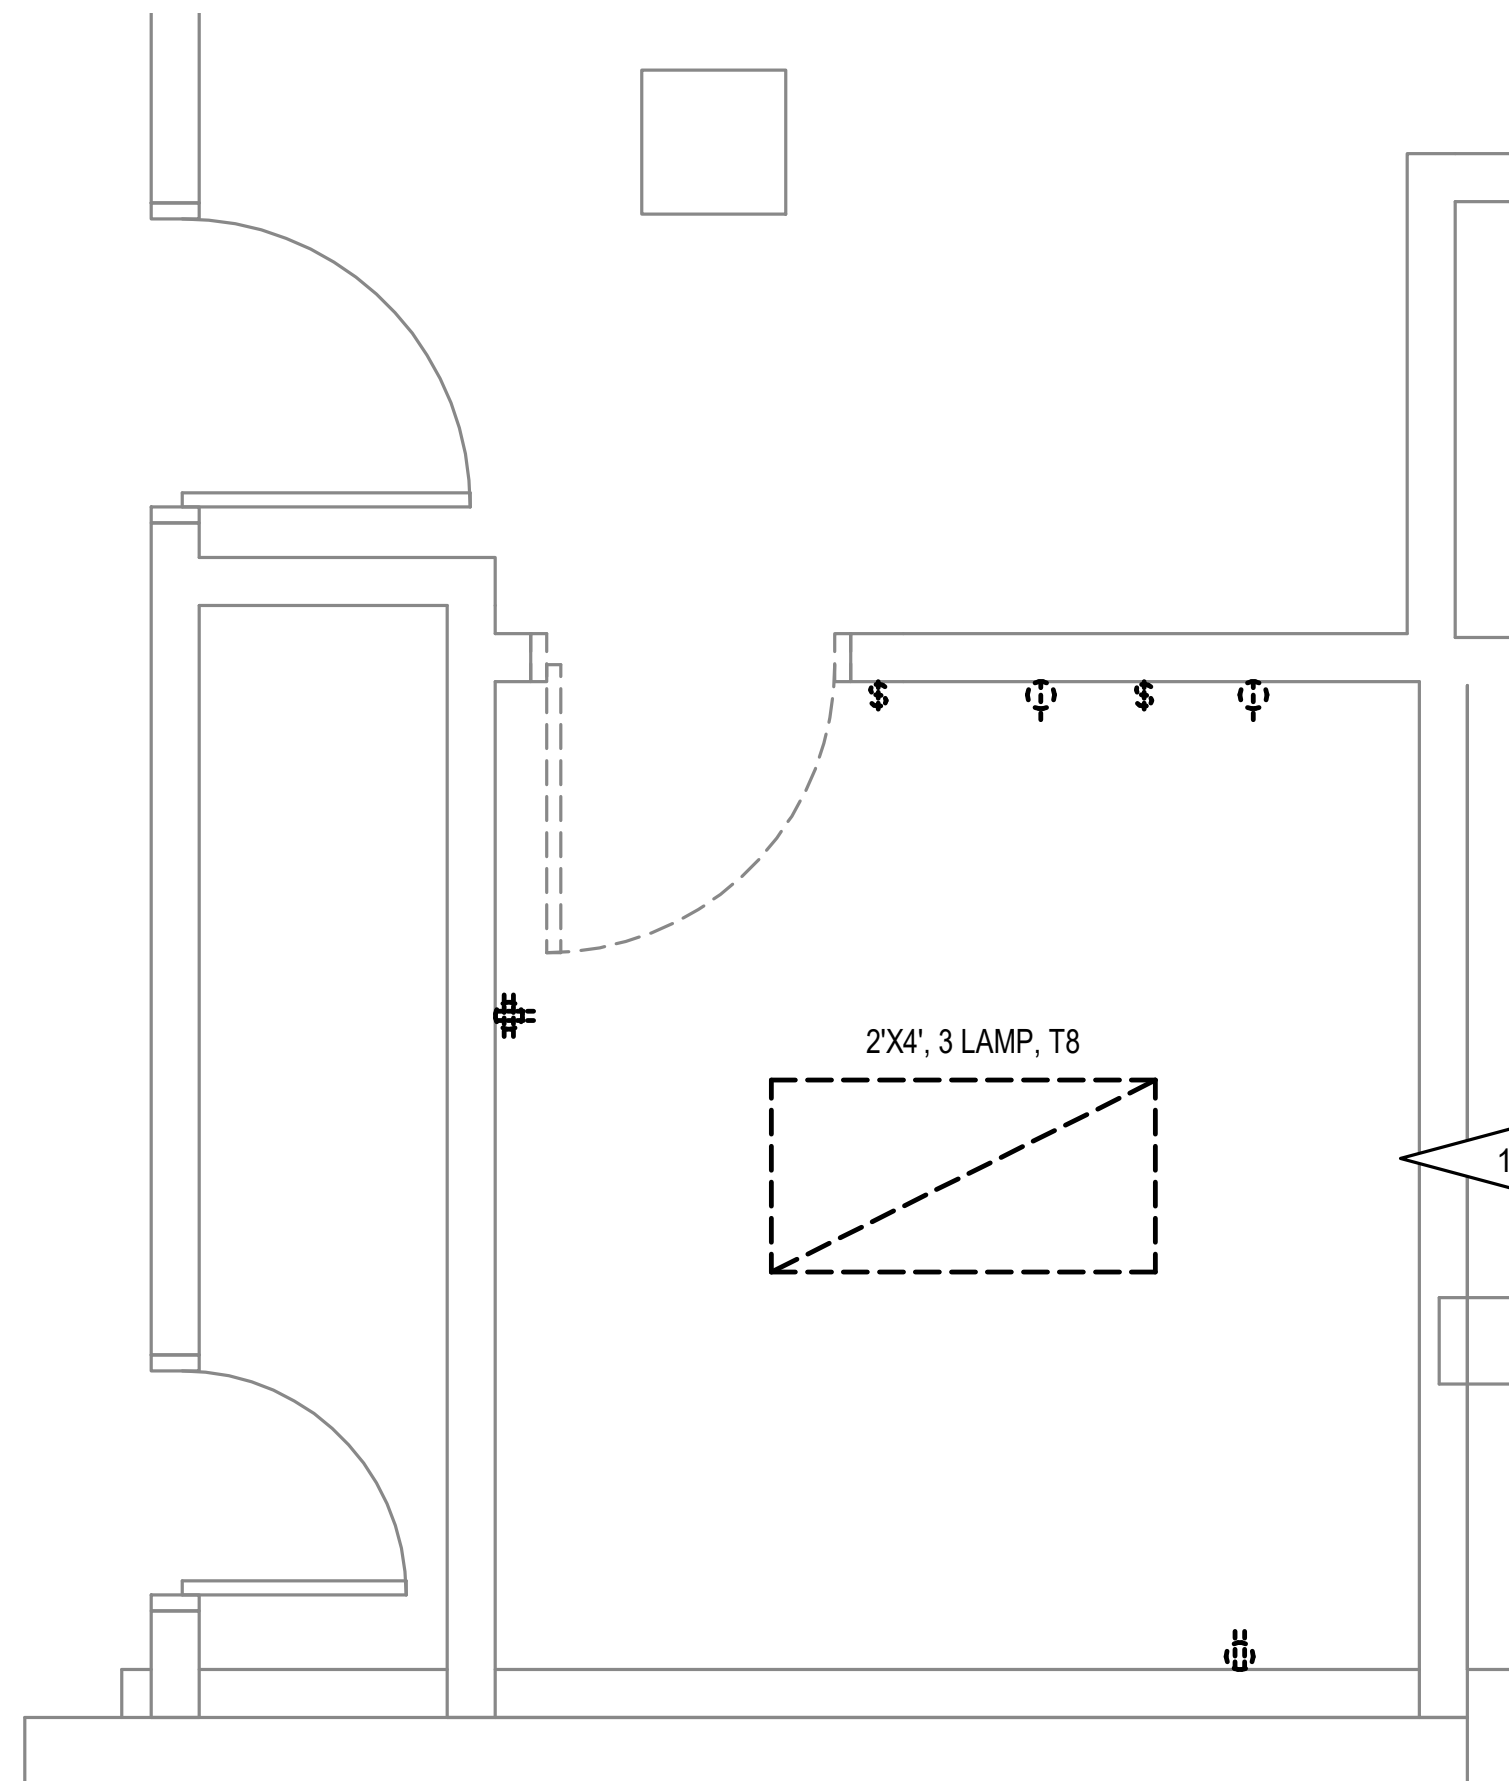

2 ENLARGED ROOM - 404C ELECTRICAL DEMOLITION
1/2" = 1'-0"

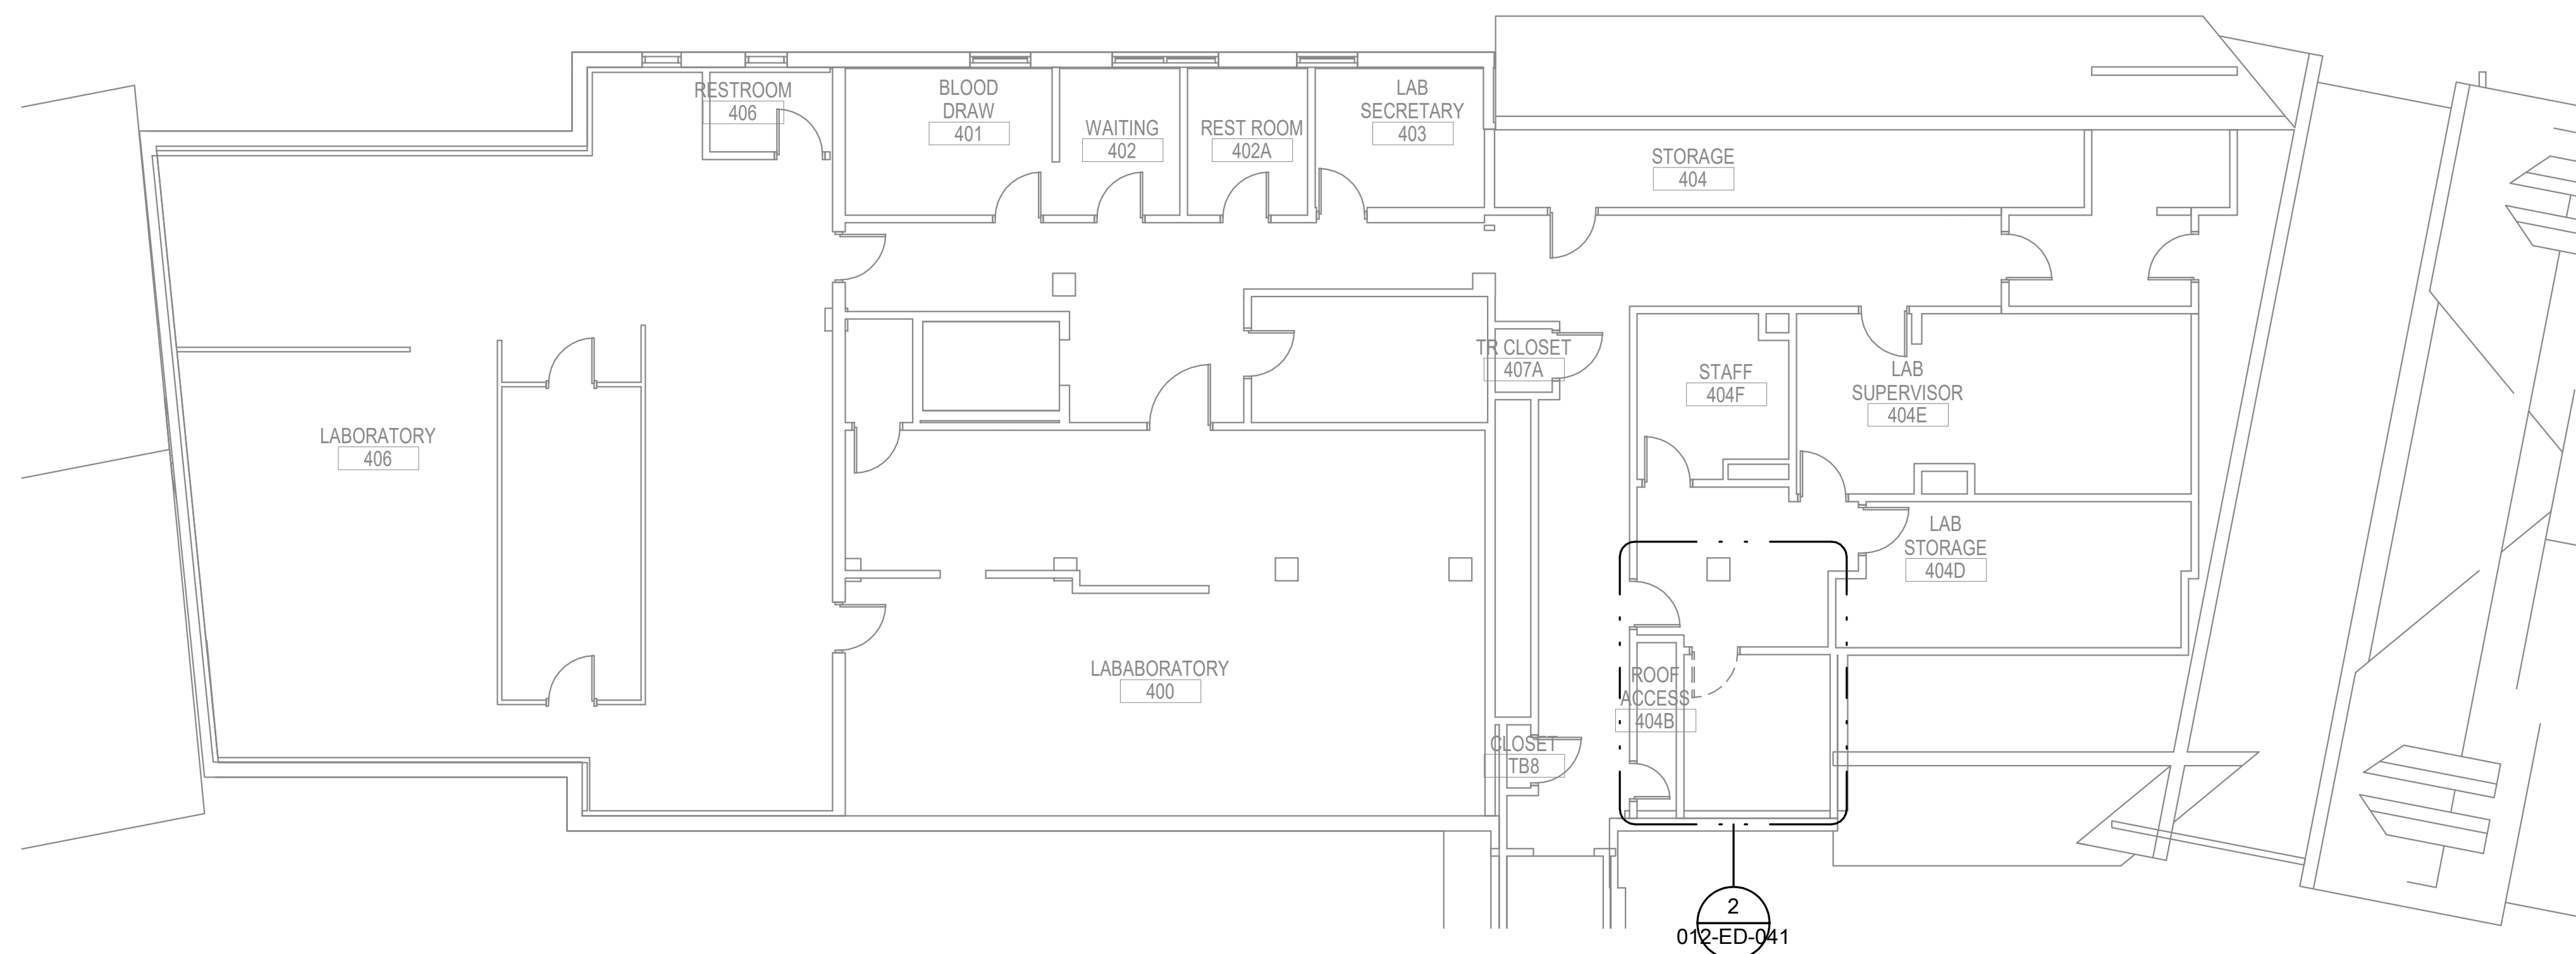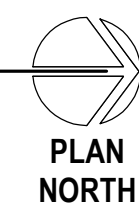

1 ELECTRICAL DEMOLITION PLAN - BLDG 12 FOURTH FLOOR
1/8" = 1'-0"

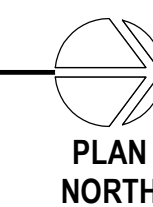[illegible]

CONSULTANT

A/E:
GDM
1000 W STEUBEN ST. UNIT 3
BINGEN, WA 98605
541.436.4723
ADAM GOODWIN, PE

GDM
ARCHITECTS • ENGINEERS

ARCHITECT/ENGINEER OF RECORD

R S A

Engineering, Inc.

MECHANICAL AND ELECTRICAL CONSULTING ENGINEERS
670 West Fireweed Lane, Suite 200
Anchorage, AK 99503
Phone (907) 276-8824
Corporate No.: AECCS42

A circular professional engineer seal for the State of Alaska. The outer ring contains the text "STATE OF ALASKA" at the top and "REGISTERED PROFESSIONAL ENGINEER" at the bottom, separated by a dashed line. Inside the ring, the text "4th DISTRICT" is at the top, followed by a five-pointed star. Below the star is the handwritten number "113847". At the bottom of the seal, the text "EXP. 6/22/2023" is printed.

**PROGRAM
CONTRACTING
ACTIVITY
CENTRAL (PCAC)**

VA | U.S. Department
of Veterans Affairs

DRAWING TITLE

**ELECTRICAL DEMO PLAN - BLDG
12 FOURTH FLOOR**


APPROVED: Project Director


PHASE	100% CD FINAL SOLUTION
FLS	FULLY SPRINKLERED

PROJECT TITLE		
EHRM INFRASTRUCTURE UPGRADES		
LOCATION		
HOT SPRINGS, SOUTH DAKOTA		
ISSUE DATE	CHECKED BY	DRAWN BY
2/22/2022	JAM	CSZ

PROJECT NUMBER 568A4-21-702
BUILDING NUMBER 12
DRAWING NUMBER 012-ED-041

SITE LEGEND

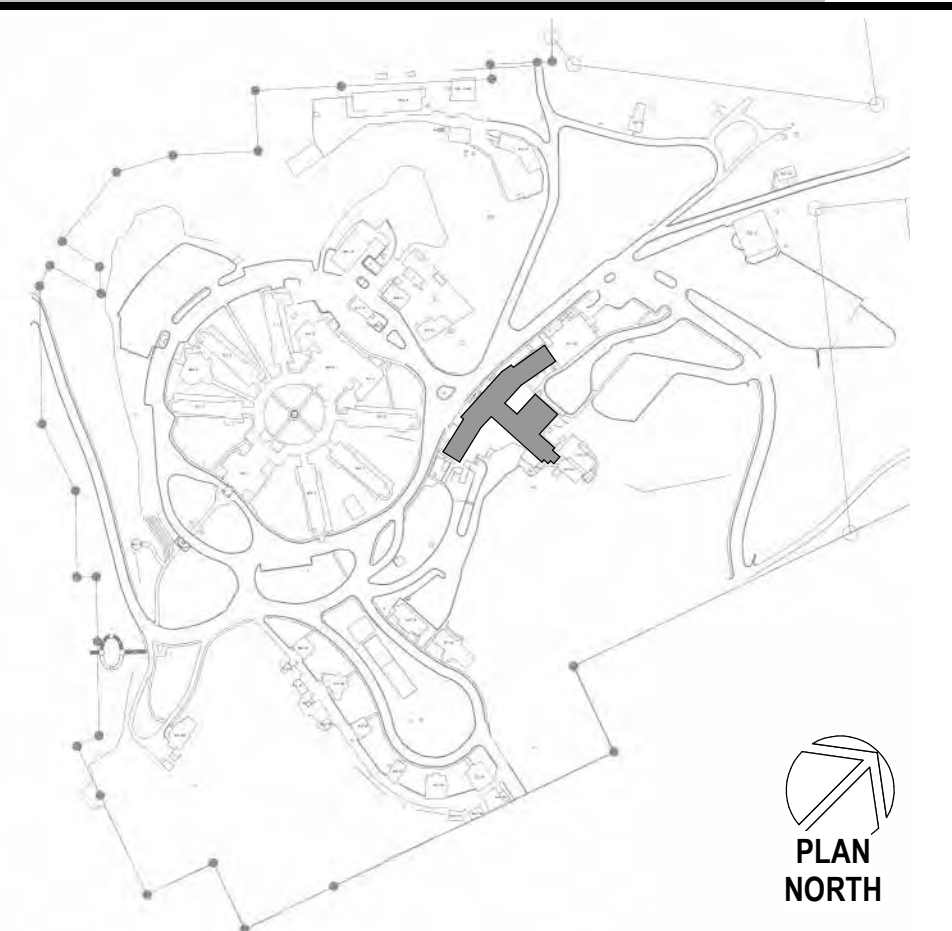


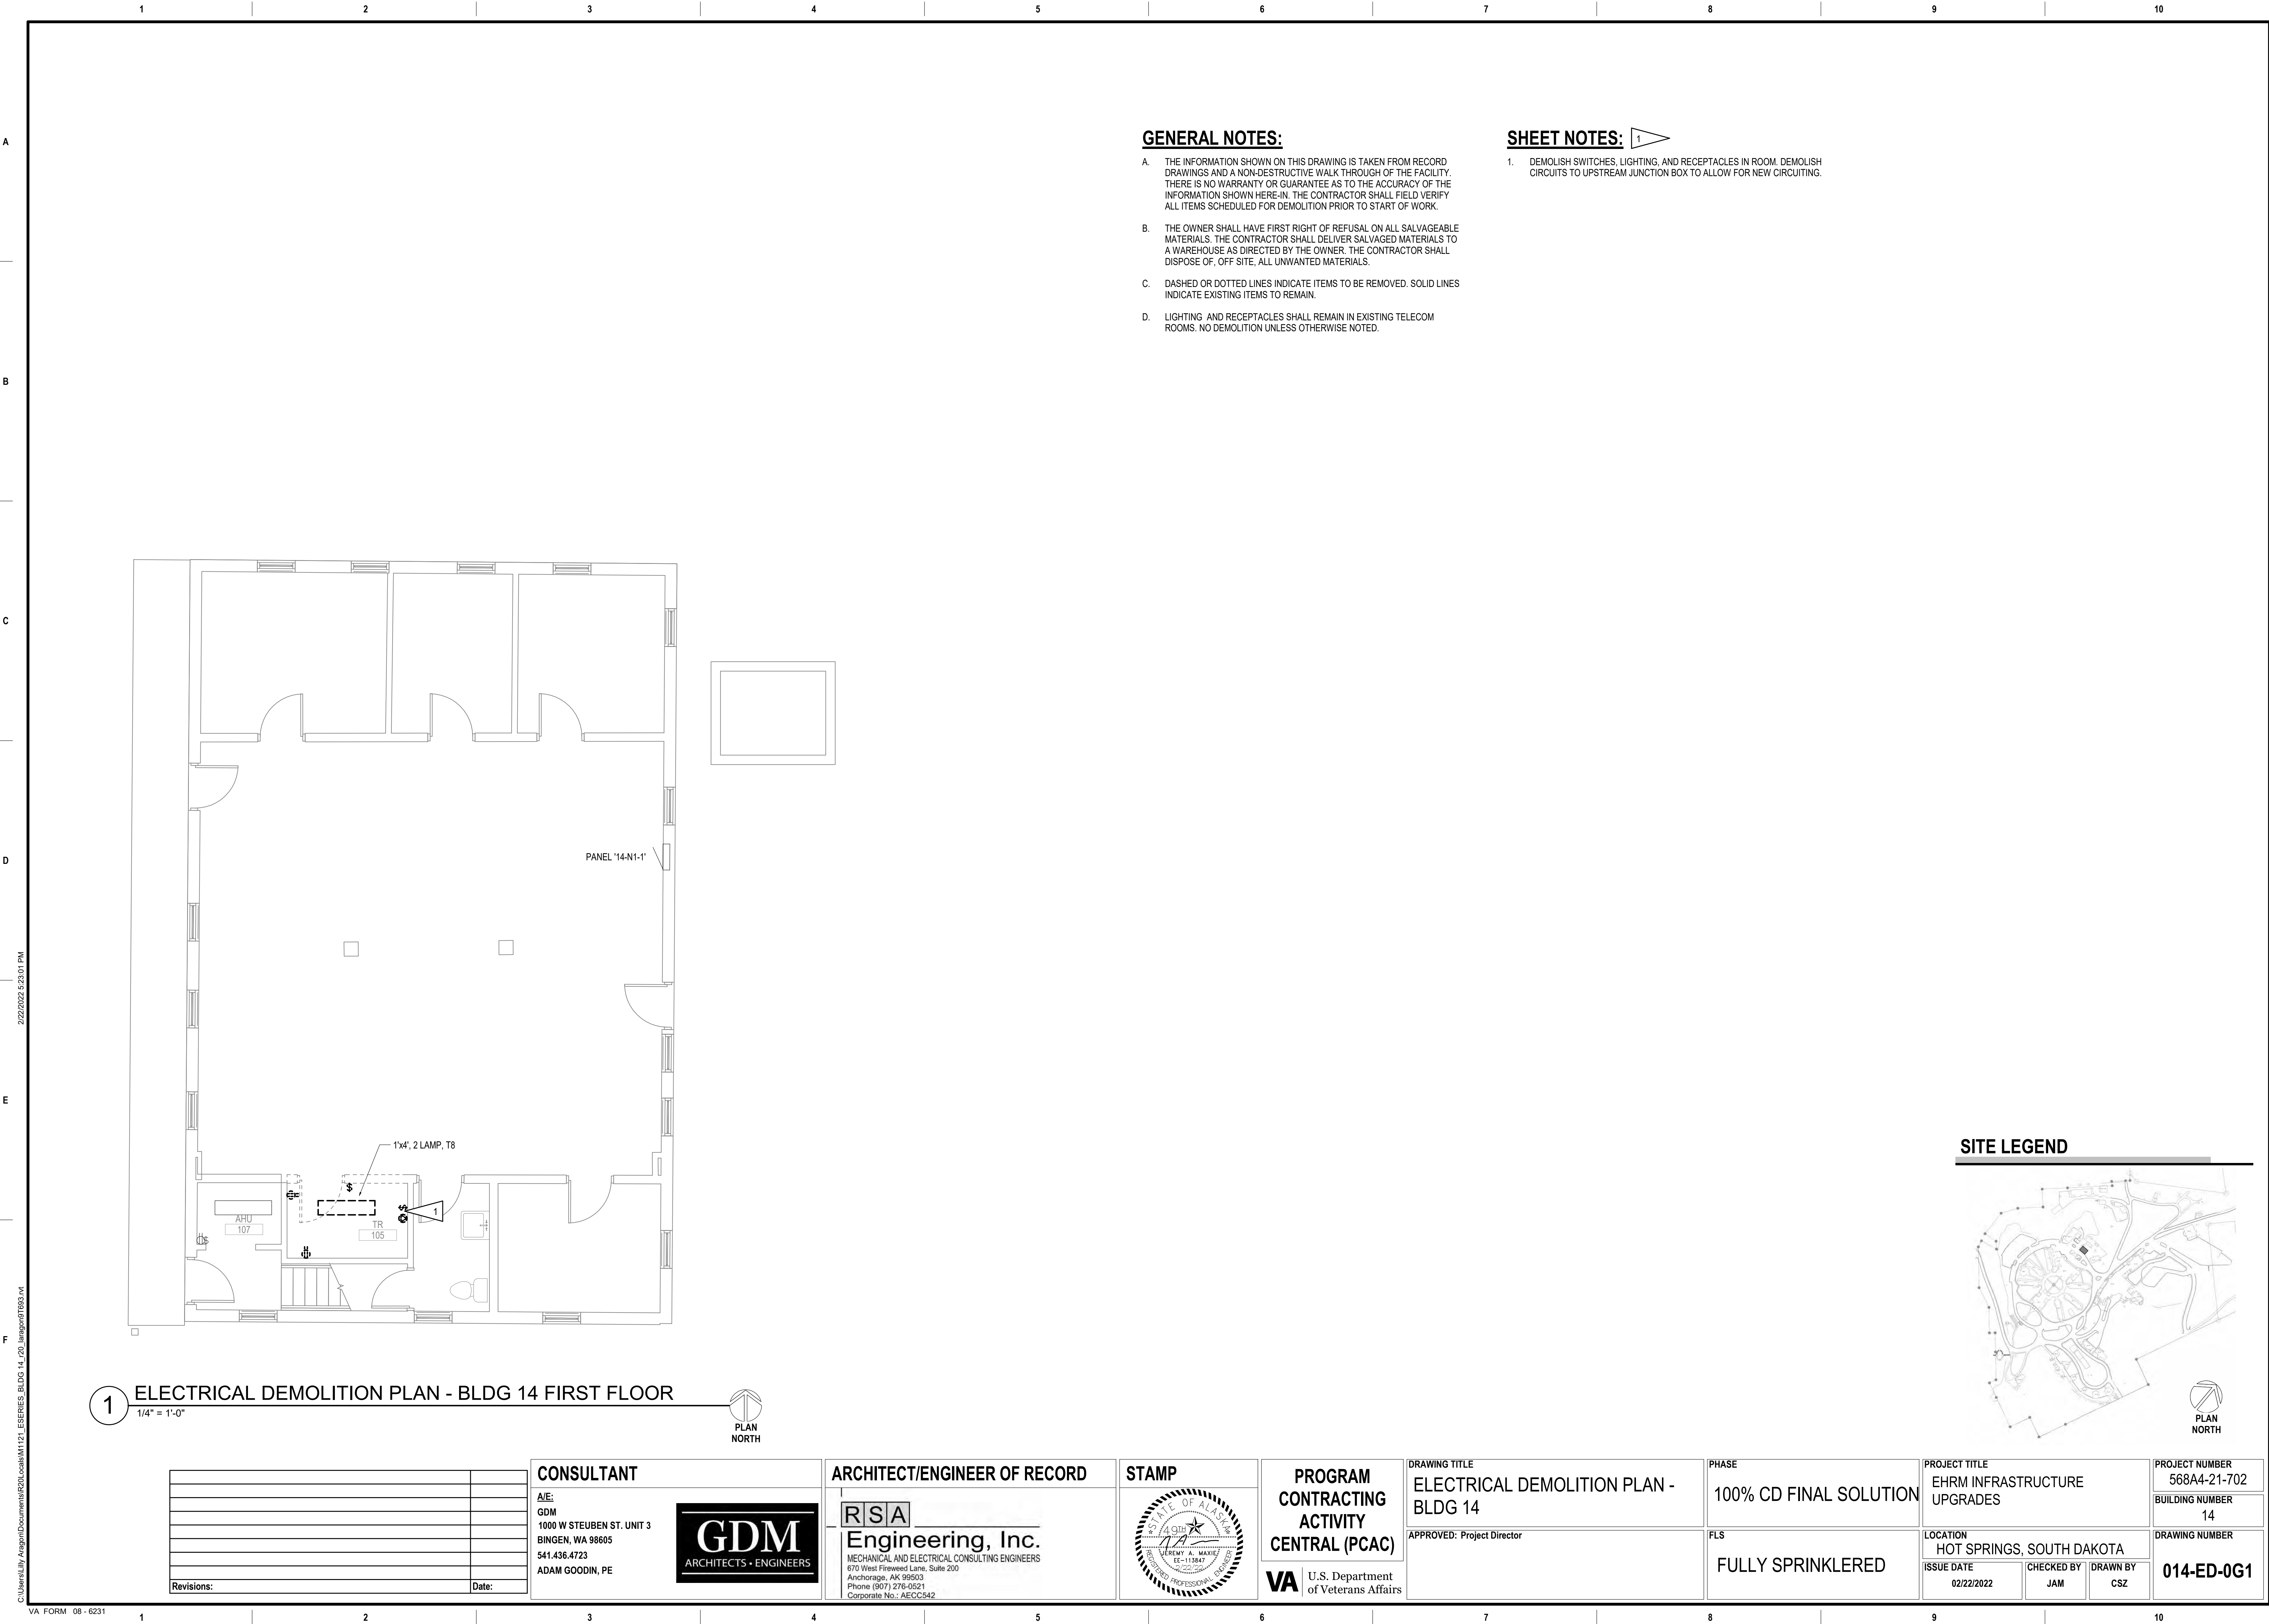

1. DEMOLISH TELECOM CABINET RECEPTACLE IN BASEMENT BELOW.
DEMOLISH RECEPTACLE CIRCUIT TO UPSTREAM JUNCTION BOX.


$$1/8'' = 1'-0''$$

PROJECT NUMBER	568A4-21-702
BUILDING NUMBER	17
DRAWING NUMBER	017-ED-011

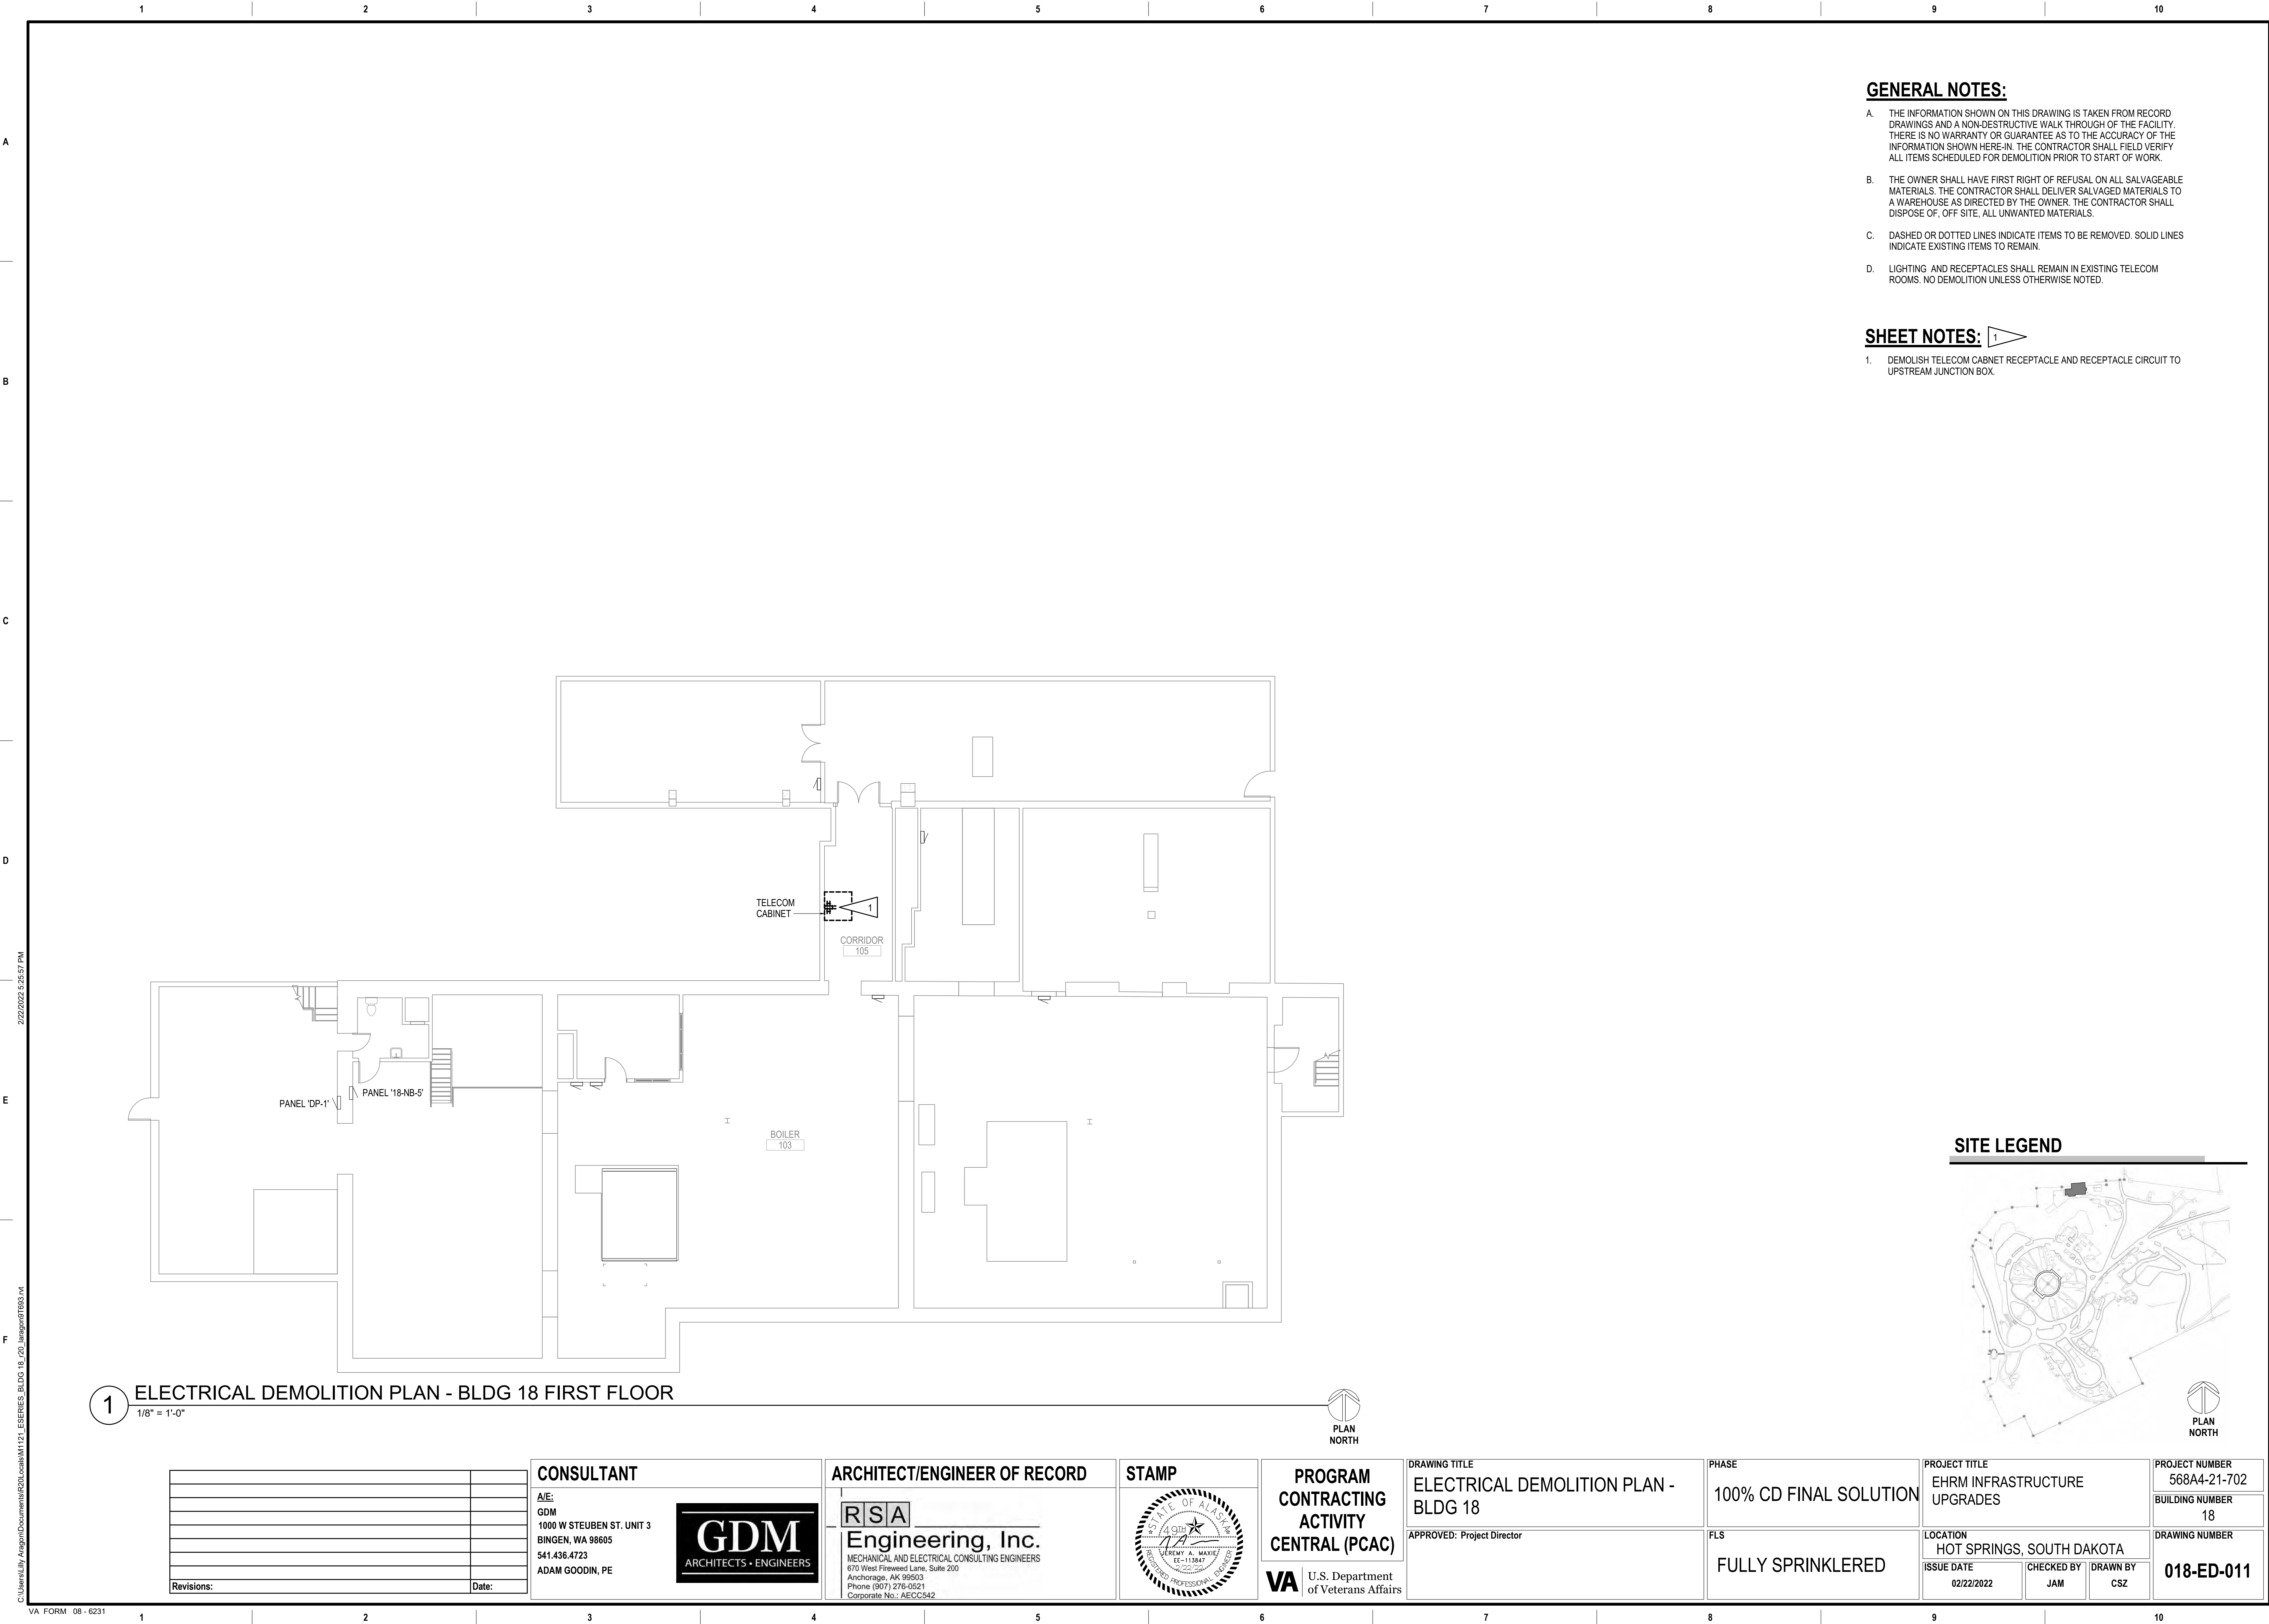

- A. THE INFORMATION SHOWN ON THIS DRAWING IS TAKEN FROM RECORD DRAWINGS AND A NON-DESTRUCTIVE WALK THROUGH OF THE FACILITY. THERE IS NO WARRANTY OR GUARANTEE AS TO THE ACCURACY OF THE INFORMATION SHOWN HERE-IN. THE CONTRACTOR SHALL FIELD VERIFY ALL ITEMS SCHEDULED FOR DEMOLITION PRIOR TO START OF WORK.
- B. THE OWNER SHALL HAVE FIRST RIGHT OF REFUSAL ON ALL SALVAGEABLE MATERIALS. THE CONTRACTOR SHALL DELIVER SALVAGED MATERIALS TO A WAREHOUSE AS DIRECTED BY THE OWNER. THE CONTRACTOR SHALL DISPOSE OF, OFF SITE, ALL UNWANTED MATERIALS.
- C. DASHED OR DOTTED LINES INDICATE ITEMS TO BE REMOVED. SOLID LINES INDICATE EXISTING ITEMS TO REMAIN.
- D. LIGHTING AND RECEPTACLES SHALL REMAIN IN EXISTING TELECOM ROOMS. NO DEMOLITION UNLESS OTHERWISE NOTED.



Revisions:	Date:

CONSULTANT

A/E:
GDM
1000 W STEUBEN ST. UNIT 3
BINGEN, WA 98605
541.436.4723
ADAM GODDIN, PE

ARCHITECT/ENGINEER OF RECORD

R S A

Engineering, Inc.

MECHANICAL AND ELECTRICAL CONSULTING ENGINEERS

670 West Firwood Lane, Suite 200
Anchorage, AK 99503
Phone (907) 276-0521

STAMP

STATE OF ALASKA
 J.A. Maxie
 JEREMY A. MAXIE
 EE-113847
 12/31/2022
 REGISTERED PROFESSIONAL ENGINEER

**PROGRAM
CONTRACTING
ACTIVITY
CENTRAL (PCAC)**

VA | U.S. Department
of Veterans Affairs

DRAWING TITLE


ELECTRICAL DEMOLITION PLAN -
BLDG 29


APPROVED: Project Director

PHASE	100% CD FINAL SOLUTION
FLS	FULLY SPRINKLERED

PROJECT TITLE		
EHRM INFRASTRUCTURE UPGRADES		
LOCATION		
HOT SPRINGS, SOUTH DAKOTA		
ISSUE DATE	CHECKED BY	DRAWN BY
02/22/2022	JAM	CSZ

PROJECT NUMBER
568A4-21-702
BUILDING NUMBER
29
DRAWING NUMBER
029-ED-0B1

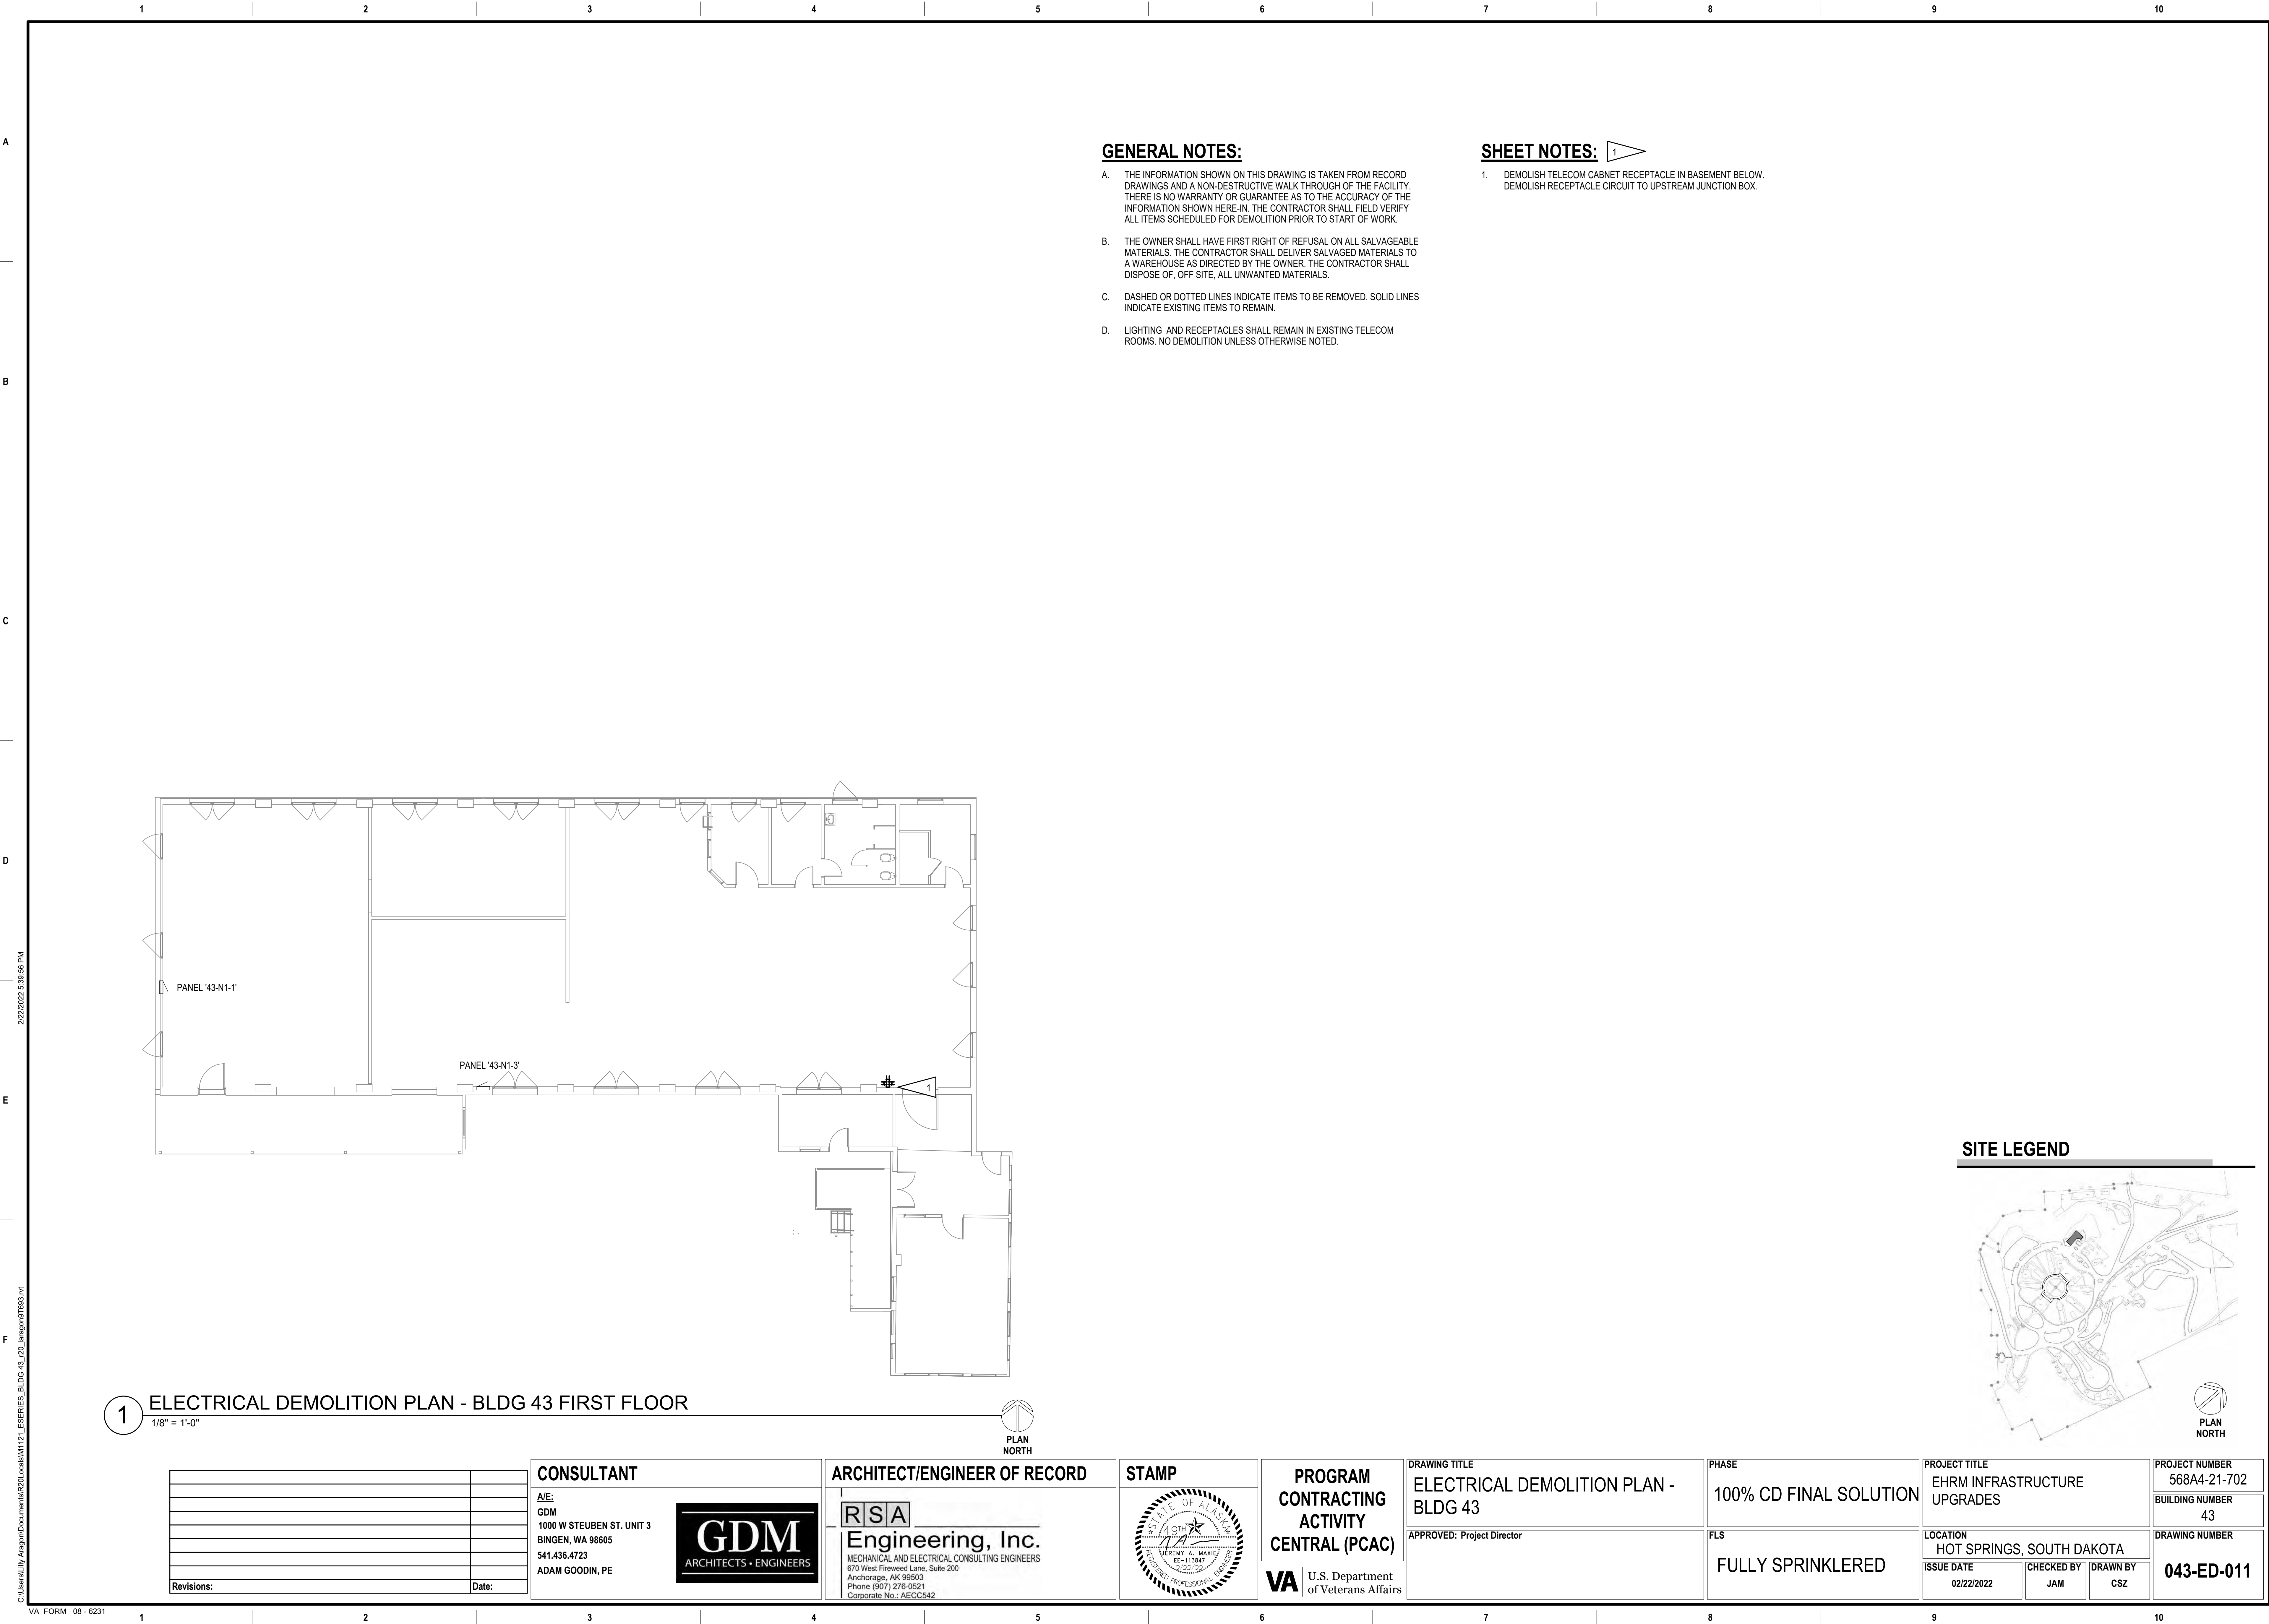

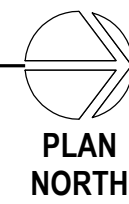


PLAN
NORTH




DRAWING NUMBER

053-ED-0B1

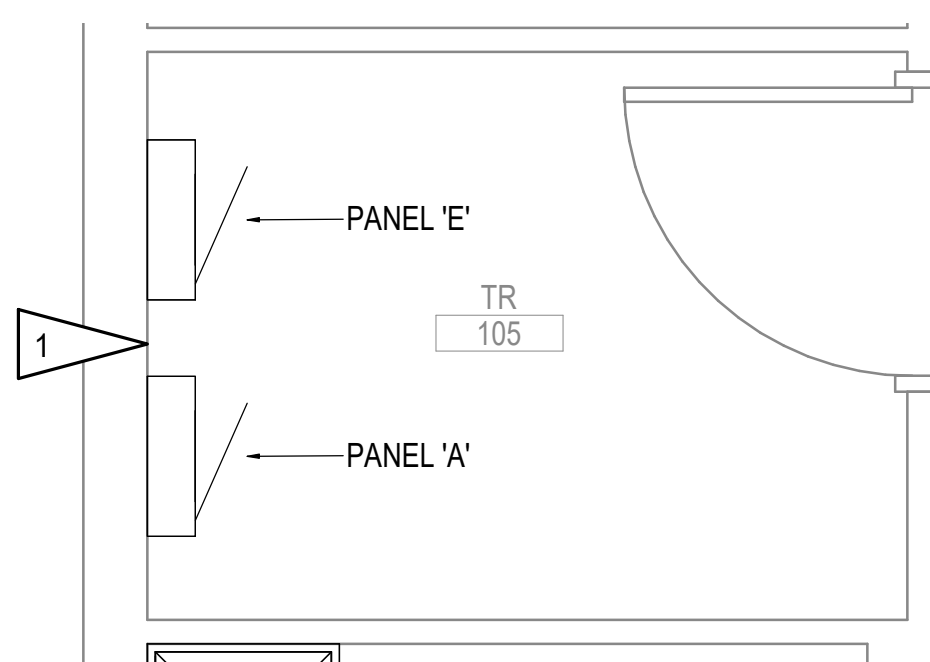

SITE LEGEND

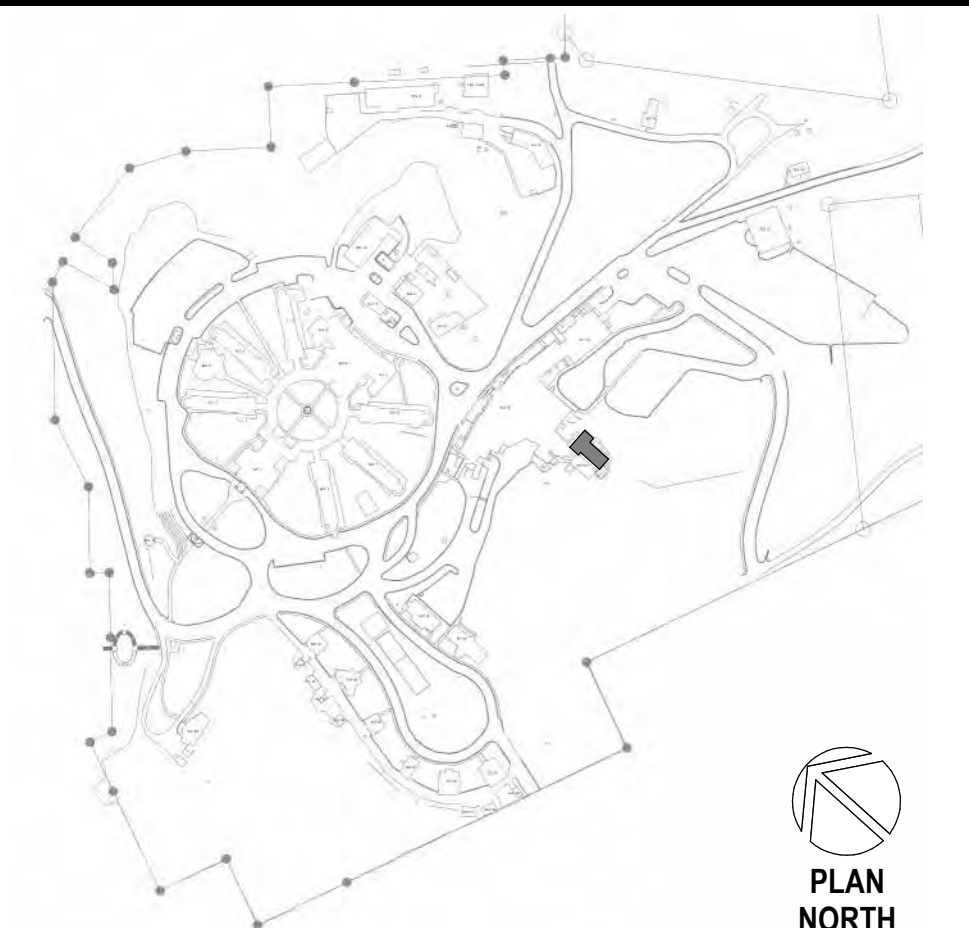

2 ENLARGED ROOM - 105 ELECTRICAL DEMOLITION
1/2" = 1'-0"


PROJECT NUMBER 568A4-21-702
BUILDING NUMBER 65
DRAWING NUMBER 065-ED-011

PROJECT NUMBER
568A4-21-702
BUILDING NUMBER
65
DRAWING NUMBER
065-ED-012


C:\Users\Liliv Aragon\Documents\R20Locals\M1121 ESERIES BLDG 65 r20 |aragon9T693.M

1	2	3	4	5	6	7	8	9	10
---	---	---	---	---	---	---	---	---	----


- A. SEE SHEET 065-ED-011 FOR GENERAL NOTES.
- B. CIRCUITING AND SWITCHING SHALL REMAIN FOR USE WITH NEW LIGHTING.

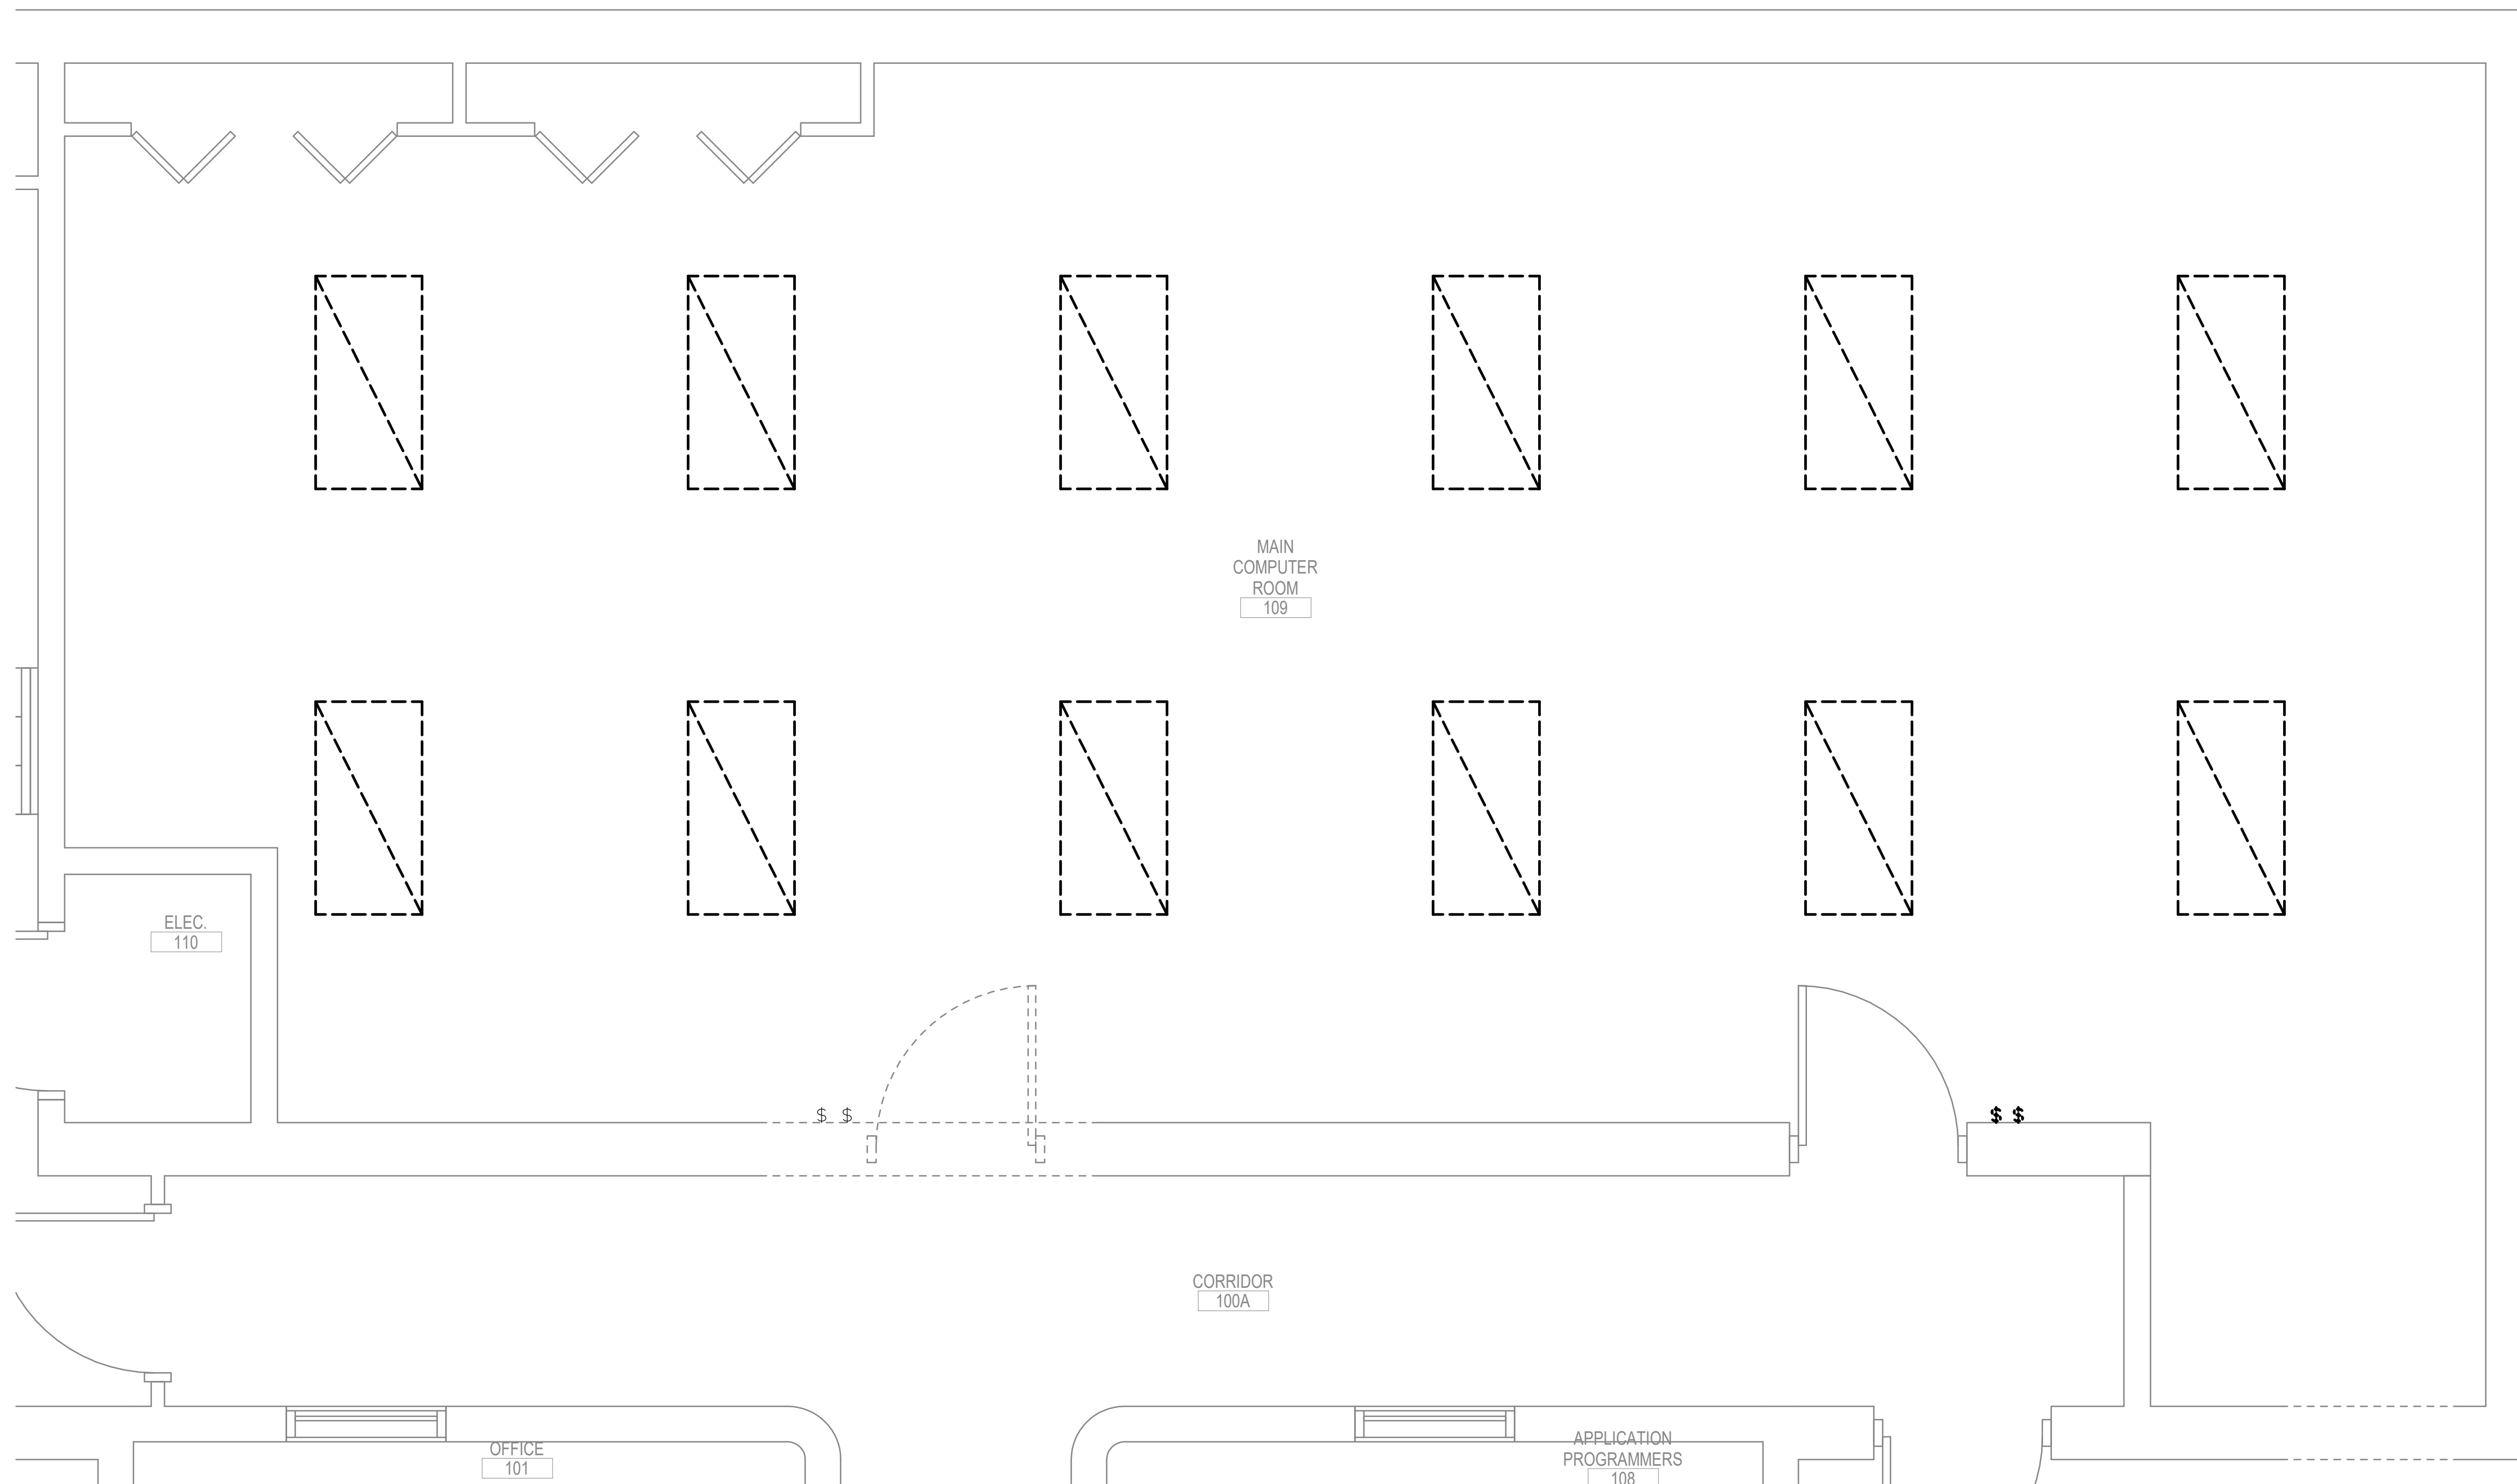

1 ENLARGED ROOM - 109 LIGHTING DEMOLITION
1/2" = 1'-0"

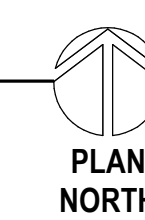

SITE LEGEND

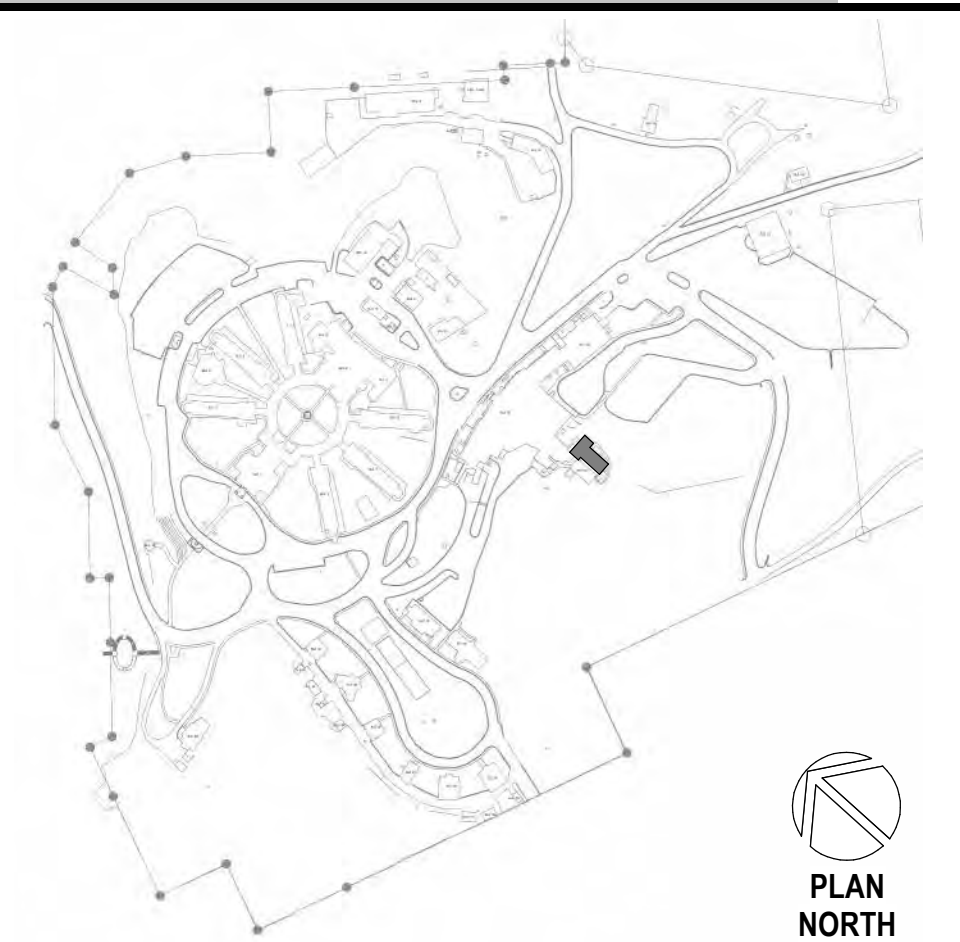[illegible]

CONSULTANT

A/E:
GDM
1000 W STEUBEN ST. UNIT 3
BINGEN, WA 98605
541.436.4723
ADAM GOODIN, PE

GDM
ARCHITECTS • ENGINEERS

ARCHITECT/ENGINEER OF RECORD

R S A

Engineering, Inc.

MECHANICAL AND ELECTRICAL CONSULTING ENGINEERS
670 West Fireweed Lane, Suite 200
Anchorage, AK 99503
Phone (907) 276-0821
Corporate No.: AECCS42

A circular professional engineer seal for the State of Alaska. The outer ring contains the text "STATE OF ALASKA" at the top and "REGISTERED PROFESSIONAL ENGINEER" at the bottom, separated by a dashed line. Inside the ring, the text "4th" is above a stylized "NA" logo. Below the logo, the name "JEREMY MAXWELL" is printed, followed by the license number "EE-113847" and the expiration date "9/22/25". A five-pointed star is positioned above the "NA" logo.

**PROGRAM
CONTRACTING
ACTIVITY
CENTRAL (PCAC)**

VA | U.S. Department
of Veterans Affairs

DRAWING TITLE	
ENLARGED LIGHTING DEMOLITION PLAN - ROOM 109	
APPROVED: Project Director	

PHASE	100% CD
FLS	FULLY SPRINKLERED

PROJECT TITLE		
EHRM INFRASTRUCTURE UPGRADES		
LOCATION		
HOT SPRINGS, SOUTH DAKOTA		
ISSUE DATE	CHECKED BY	DRAWN BY
02/22/2022	JAM	NVF

PROJECT NUMBER 568A4-21-702
BUILDING NUMBER 65
DRAWING NUMBER 065-ED-013

A. SEE SHEET EK-101 FOR FEEDER SCHEDULE.

1. INSTALL NEW CIRCUIT BREAKERS ON THE EXISTING PULVIN IN BUSSED DUCT. THE EXISTING DUCT IS A WESTINGHOUSE TYPE POW-R-WAY BUSWAY, 800A, 120/208V, 3Ø, 4-WIRE. THE NEW CIRCUIT BREAKERS SHALL BE COMPATIBLE WITH AND LISTED FOR USE IN THE EXISTING BUSSED DUCT AND SHALL HAVE A MINIMUM SHORT CIRCUIT AIR C RATING OF 30,000 OR MATCH THE LOWEST RATED EXISTING DEVICE IN THE BUSSED DUCT, WHICH EVER IS LARGER.
2. INSTALL NEW CIRCUIT BREAKER IN SPACE AVAILABLE IN THE EXISTING PANEL. THE EXISTING PANEL IS A WESTINGHOUSE TYPE COP, 600A, 120/208V, 3Ø, 4-WIRE WITH MAIN LUGS ONLY. THE NEW CIRCUIT BREAKERS SHALL BE COMPATIBLE WITH AND LISTED FOR USE IN THE EXISTING PANEL AND SHALL HAVE A MINIMUM SHORT CIRCUIT AIR C RATING OF 20,000 OR MATCH THE LOWEST RATED EXISTING DEVICE IN THE PANEL, WHICH EVER IS LARGER.
3. INSTALL NEW CIRCUIT BREAKERS IN SPACE AVAILABLE IN THE EXISTING PANEL. THE EXISTING SWITCHBOARD IS A WESTINGHOUSE, 1600A, 120/208V, 3Ø. THE NEW CIRCUIT BREAKER SHALL BE COMPATIBLE WITH AND LISTED FOR USE IN THE EXISTING SWITCHBOARD AND SHALL HAVE A MINIMUM SHORT CIRCUIT AIR C RATING TO MATCH THE LOWEST RATED EXISTING DEVICE IN THE SWITCHBOARD.
4. SEE EQUIPMENT SCHEDULE ON SHEET 010-EP-0B1 FOR FEEDER SIZE.



CONSULTANT


A/E:
GDM
1000 W STEUBEN STR, UNIT 3
BINGEN, WA 98605
541.436.4723
ADAM GOODIN, PE

A circular professional engineer stamp for the State of Alaska. The outer ring contains the text "STATE OF ALASKA" at the top and "REGISTERED PROFESSIONAL ENGINEER" at the bottom, separated by a dashed line. Inside the ring, a five-pointed star is positioned above the name "JEREMY A. ERICKSON". Below the name is the license number "EE-113547" and the expiration date "3/19/22". The stamp also includes the text "40TH" and "ANALYSIS" near the star.

DRAWING TITLE	
POWER ONE-LINE DIAGRAM NORMAL BRANCH - DOM	
APPROVED: Project Director	


PROJECT TITLE		
EHRM INFRASTRUCTURE UPGRADES		
LOCATION		
HOT SPRINGS, SOUTH DAKOTA		
ISSUE DATE	CHECKED BY	DRAWN BY
02/22/2022	JAM	PCC

PROJECT NUMBER
568A4-21-702
BUILDING NUMBER
N/A
DRAWING NUMBER
EK-102

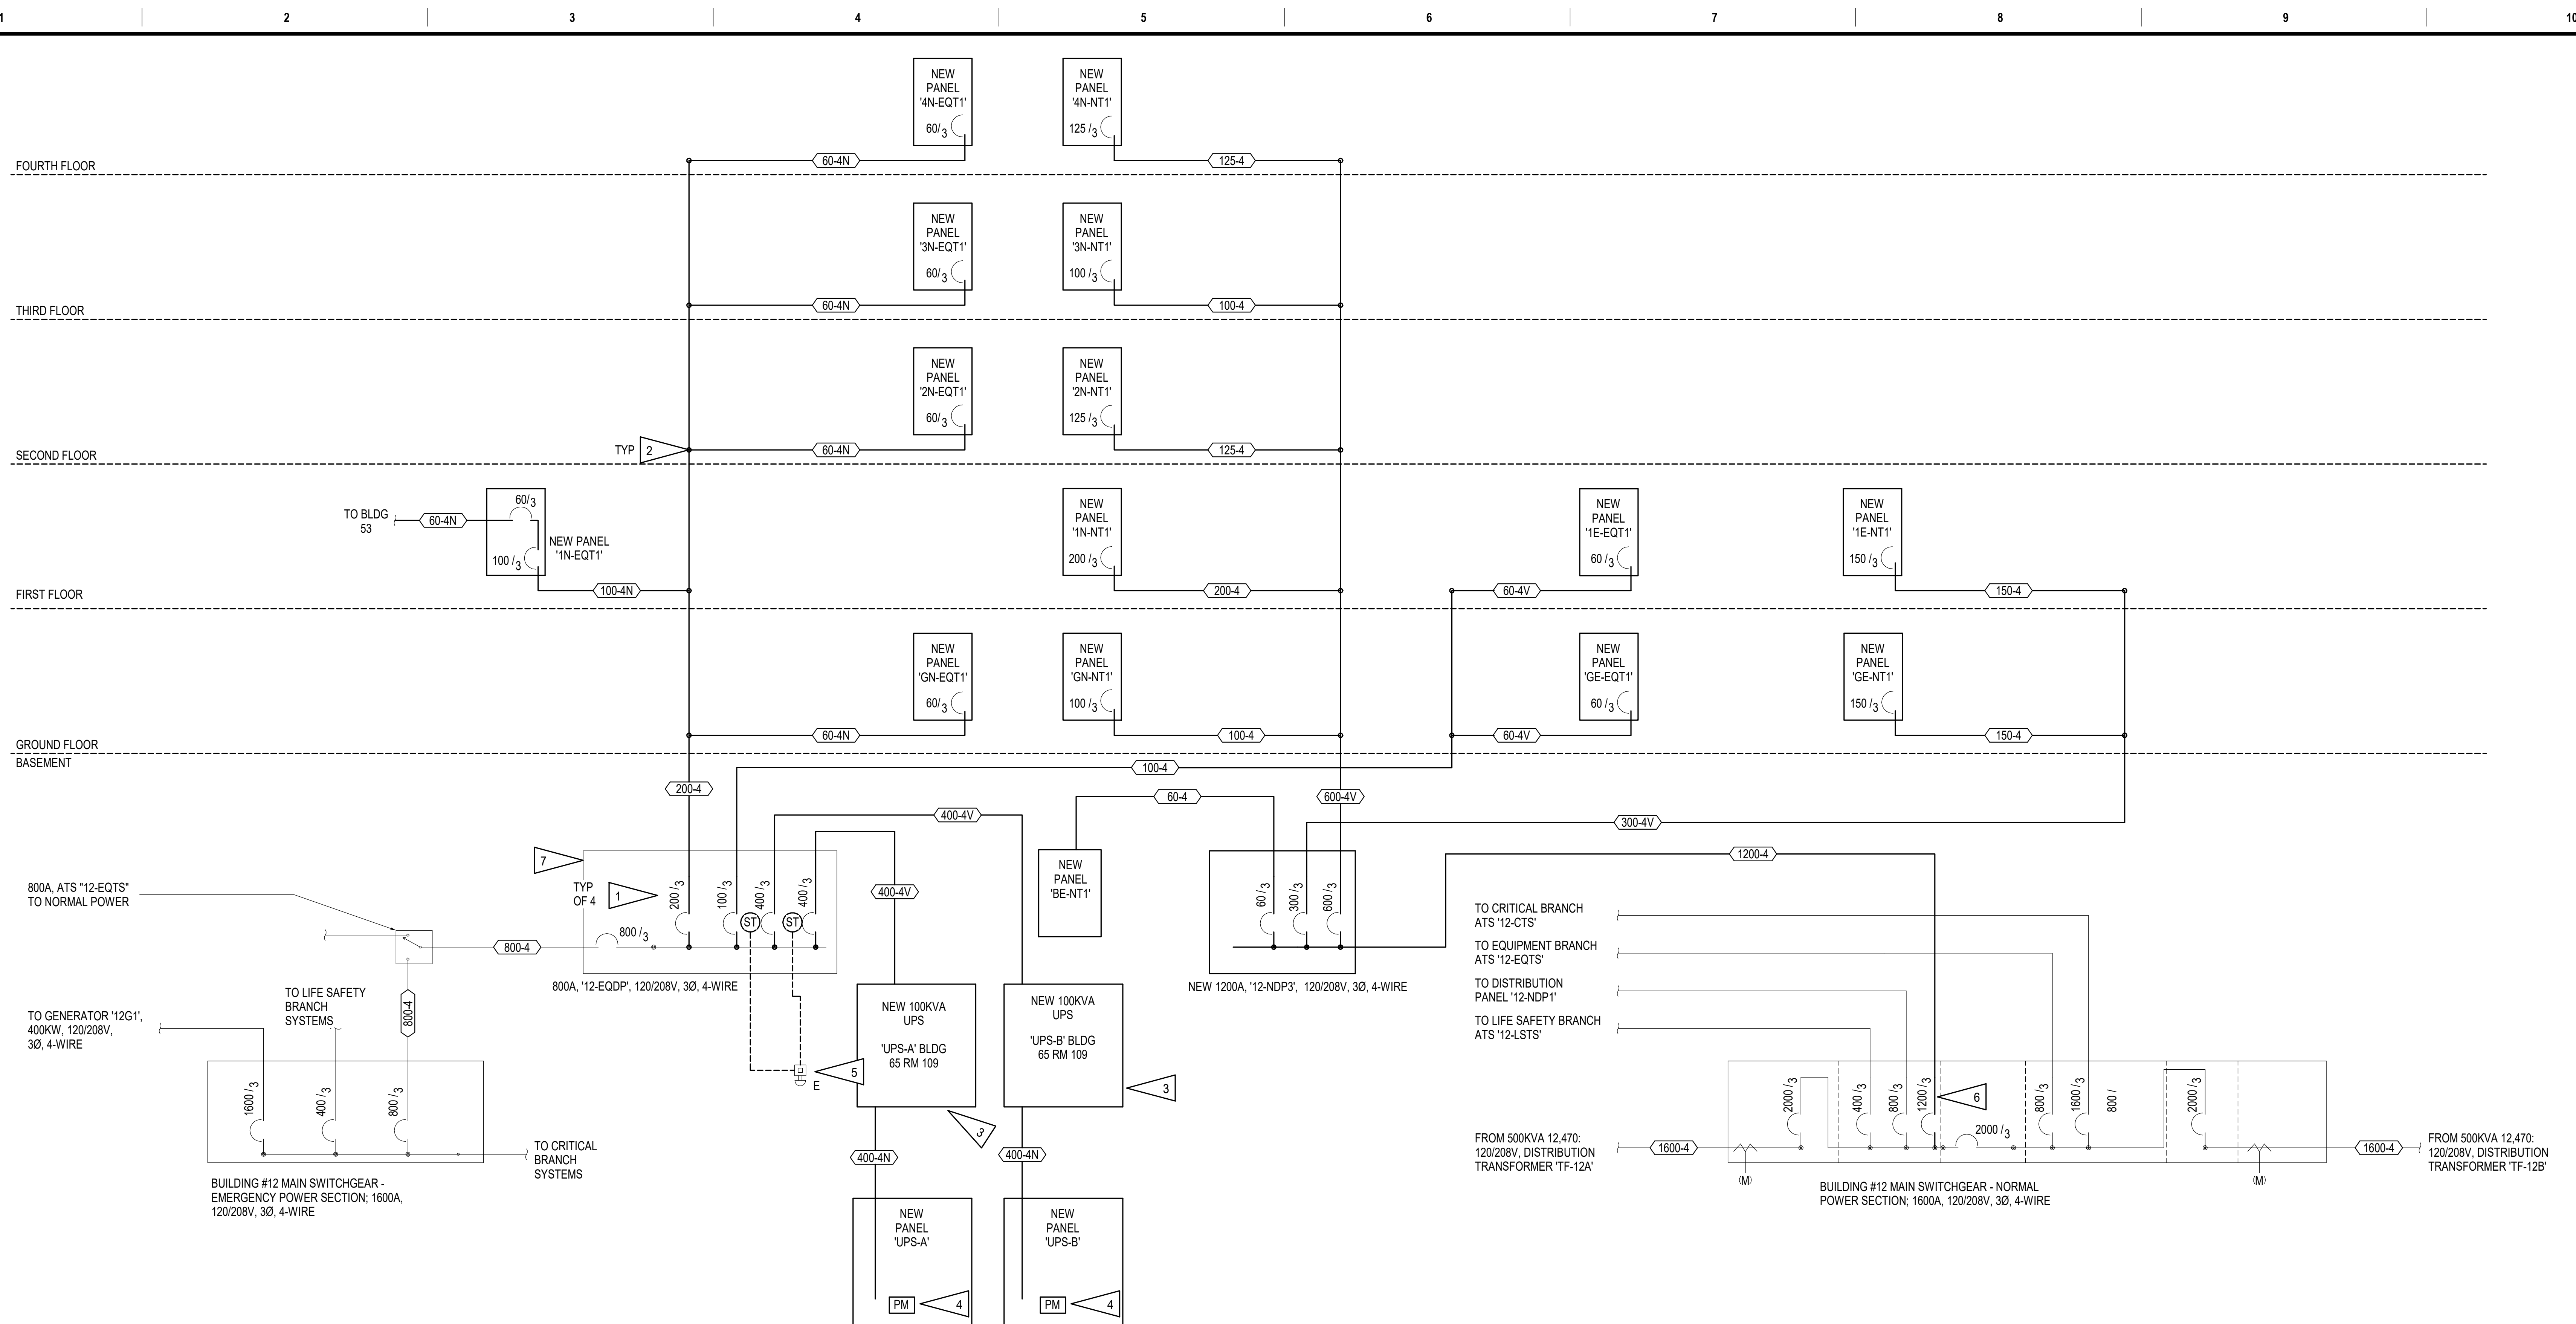

SHEET NOTES:

 [illegible]



3 CONTROLLED DOOR - SINGLE DOOR, ELECTRIFIED EXIT DEVICE

NEW ELECTRIFIED EXIT DEVICE
WITH LATCHBOLT MONITORING AND
REQUEST-TO-EXIT SWITCH

PROJECT NUMBER	568A4-21-702
BUILDING NUMBER	N/A
DRAWING NUMBER	EK-104

A

B

C

D

E

F

C:\Users\Caleb\AppData\Local\Microsoft\OneDrive\OneDrive\Documents\REVIT 2020 LOCAL\SM1121 ESERIES_BLDG 1\201_40pp\DCETM.rvt

C:\Users\Caleb\AppData\Local\Microsoft\OneDrive\OneDrive\Documents\REVIT 2020 LOCAL\SM1121 ESERIES_BLDG 1\201_40pp\DCETM.rvt

PANEL '1-EQ1-T1'																									
MFR/MODEL: SQUARE 'D' TYPE NQ												VOLTS: 120/208V,3PH,4W													
ENCLOSURE: NEMA 1												100 A													
MTG: SURFACE												VOLT-AMPS													
NOTE	CIRC	POLE	AMPS	SERVICE			TYPE	A			B			C			TYPE	SERVICE			AMPS	POLE	CIRC	NOTE	
1	3	20	20	RK-113C-1A			MISC	1,667	250							LTG	TELECOM RM 113C LTG			20	1	2			
3	3	20	20	AAA			MISC				1,667	50				MISC	1-DDC-2			15	1	4			
5	3	20	20	AAA			MISC							1,667			SPARE			20	1	6			
7	1	-	-	SPACE													SPACE			-	1	8			
9	1	-	-	SPACE													SPACE			-	1	10			
11	1	-	-	SPACE													SPACE			-	1	12			
13	1	-	-	SPACE													SPACE			-	1	14			
15	1	-	-	SPACE													SPACE			-	1	16			
17	1	-	-	SPACE													SPACE			-	1	18			
19	1	-	-	SPACE													SPACE			-	1	20			
TOTAL V-A								1,917			1,717			1,667			5,300			VA					
TOTAL AMPS								16			14			14			15			A					
A.I.C. RATING: 10,000																									
								LTG	REC	MOTR	LG.MT	MISC	KIT	HEAT	SPEC	TOTAL			AMPS						
CONNECTED LOAD IN KVA (THIS PANEL):								0.25	0.00	0.00	0.00	5.05	0.00	0.00	0.00	5.3 KVA			15			A			
CONNECTED LOAD IN KVA (BRANCH PANELS):								0.25	0.00	0.00	0.00	5.05	0.00	0.00	0.00	0.0 KVA			0			A			
TOTAL CONNECTED LOAD IN KVA:								0.25	0.00	0.00	0.00	5.05	0.00	0.00	0.00	5.3 KVA			15			A			
DEMAND LOAD IN KVA:								0.31	0.00	0.00	0.00	5.05	0.00	0.00	0.00	5.4 KVA			15			A			
PANEL NOTES:												PANEL OPTIONS:													
a FED FROM PANEL 2-EQ0B-2.												MAIN CIRCUIT BREAKER (SEE ONE-LINE FOR SIZE)													

PANEL '1-EQ2-T1'																									
MFR/MODEL: SQUARE 'D' TYPE NQ												VOLTS: 120/208V,3PH,4W													
ENCLOSURE: NEMA 1												100 A													
MTG: SURFACE												VOLT-AMPS													
NOTE	CIRC	POLE	AMPS	SERVICE			TYPE	A			B			C			TYPE	SERVICE			AMPS	POLE	CIRC	NOTE	
1	3	20	20	RK-217C-1A			MISC	1,667	250							1	TELECOM RM 217C LTG			20	1	2			
3	3	20	20	AAA			MISC				1,667	50				MISC	1-DDC-3			15	1	4			
5	3	20	20	AAA			MISC							1,667				SPARE	20	1	6				
7	1	-	-	SPACE													SPACE	-	1	8					
9	1	-	-	SPACE													SPACE	-	1	10					
11	1	-	-	SPACE													SPACE	-	1	12					
13	1	-	-	SPACE													SPACE	-	1	14					
15	1	-	-	SPACE													SPACE	-	1	16					
17	1	-	-	SPACE													SPACE	-	1	18					
19	1	-	-	SPACE													SPACE	-	1	20					
TOTAL V-A								1,917			1,717			1,667			5,300			VA					
TOTAL AMPS								16			14			14			15			A					
A.I.C. RATING: 10,000																									
CONNECTED LOAD IN KVA (THIS PANEL): CONNECTED LOAD IN KVA (BRANCH PANELS): TOTAL CONNECTED LOAD IN KVA: DEMAND LOAD IN KVA:								LTG	REC	MOTR	LG.MT	MISC	KIT	HEAT	SPEC	TOTAL			AMPS						
								0.25	0.00	0.00	0.00	5.05	0.00	0.00	0.00	5.3 KVA			15			A			
								0.25	0.00	0.00	0.00	5.05	0.00	0.00	0.00	0.0 KVA			0			A			
								0.31	0.00	0.00	0.00	5.05	0.00	0.00	0.00	5.3 KVA			15			A			
PANEL NOTES: a FED FROM PANEL 2-EQ0B-2.												PANEL OPTIONS: MAIN CIRCUIT BREAKER (SEE ONE-LINE FOR SIZE)													

PANEL '1-EQ3-T1'																													
MFR/MODEL: SQUARE 'D' TYPE NQ												VOLTS: 120/208V,3PH,4W						ENCLOSURE: NEMA 1						100 A					
NOTE	CIRC	POLE	AMPS	SERVICE			TYPE	VOLT-AMPS						MTG. SURFACE															
								A		B		C		TYPE	SERVICE		AMPS	POLE	CIRC	NOTE									
1	3	20	20	RK-315C-1A			MISC	1,667	350		1,667	50		1,667		LTG	TELECOM RM LTG		20	1	2								
3	3	20	20	AAA			MISC									MISC	1-DDC-4		15	1	4								
5	3	20	20	AAA			MISC										SPARE		20	1	6								
7	1	-	-	SPACE													SPACE		-	1	8								
9	1	-	-	SPACE													SPACE		-	1	10								
11	1	-	-	SPACE													SPACE		-	1	12								
13	1	-	-	SPACE													SPACE		-	1	14								
15	1	-	-	SPACE													SPACE		-	1	16								
17	1	-	-	SPACE													SPACE		-	1	18								
19	1	-	-	SPACE													SPACE		-	1	20								
TOTAL V-A								2,017		1,717		1,667		5,400		VA													
TOTAL AMPS								17		14		14		15		A													
A.I.C. RATING: 10,000																													
								LTG	RECP	MOTR	LG.MT	MISC	KIT	HEAT	SPEC	TOTAL				AMPS									
CONNECTED LOAD IN KVA (THIS PANEL):								0.35	0.00	0.00	0.00	5.05	0.00	0.00	0.00	5.4 KVA		15		A									
CONNECTED LOAD IN KVA (BRANCH PANELS):																0.0 KVA		0		A									
TOTAL CONNECTED LOAD IN KVA:								0.35	0.00	0.00	0.00	5.05	0.00	0.00	0.00	5.4 KVA		15		A									
DEMAND LOAD IN KVA:								0.44	0.00	0.00	0.00	5.05	0.00	0.00	0.00	5.5 KVA		15		A									
PANEL NOTES: a FED FROM PANEL '2-EQ0B-2'.												PANEL OPTIONS: MAIN CIRCUIT BREAKER (SEE ONE-LINE FOR SIZE)																	

PANEL '2-EQB-T'

MFR/MODEL: SQUARE 'D' TYPE NQ

VOLTS: 120/208/3PH/4W

ENCLOSURE: NEMA 1

100 A

NOTE	CIRC	POLE	AMPS	SERVICE	TYPE	VOLT-AMPS			MTG.	SURFACE	SERVICE	AMPS	POLE	CIRC	NOTE
						A	B	C							
1	3	-	20	RK-B1B-1A	MISC	1,667	170		LTG		TELECOM RM B1B, VEST B1C LTG	20	1	2	
3	3	-	20	AAA	MISC		1,667	50		MISC	2-DDC-1	15	1	4	
5	3	-	20	AAA	MISC			1,667			SPARE	20	1	6	
7	1	-	20	SPARE							SPARE	20	1	8	
9	1	-		SPACE							SPACE	-	1	10	
11	1	-		SPACE							SPACE	-	1	12	
13	1	-		SPACE							SPACE	-	1	14	
15	1	-		SPACE							SPACE	-	1	16	
17	1	-		SPACE							SPACE	-	1	18	
19	1	-		SPACE							SPACE	-	1	20	
TOTAL VA						1,837	1,717	1,667				5,220	VA		
TOTAL AMPS						15	14	14				14	A		
A.I.C. RATING: 22,000															
CONNECTED LOAD IN KVA (THIS PANEL): CONNECTED LOAD IN KVA (BRANCH PANELS) TOTAL CONNECTED LOAD IN KVA: DEMAND LOAD IN KVA:												TOTAL		AMPS	
												5.2 KVA	14	A	
												0.0 KVA	0	A	
												5.2 KVA	14	A	
												5.3 KVA	15	A	

PANEL NOTES:
a FED FROM PANEL '2-EQGB-Z'.

PANEL OPTIONS:
MAIN CIRCUIT BREAKER (SEE ONE-LINE FOR SIZE)

PROJECT NUMBER
568A4-21-702
BUILDING NUMBER
N/A
DRAWING NUMBER
EK-106

PANEL '2-EQD-2'				VOLTS: 120/208V,3PH,4W				ENCLOSURE: NEMA 1				400 A			
MFR/MODEL: SQUARE 'D' TYPE I-LINE															
NOTE	POLE	AMPS	SERVICE	TYPE	A	VOLT-AMPS		C	MTG: SURFACE	SERVICE	AMPS	POLE	NOTE		
3	*	AAA	BUILDING 1 TR FEEDER	FEDR	7,811	:	3,533		FEDR	BUILDING 3 TR FEEDER	*	3			
3	*	AAA		FEDR		6,867	3,383		FEDR	AAA	*	3			
3	*	AAA		FEDR				6,667	3,333		*	3			
3	*	AAA	BUILDING 2 TR FEEDER	FEDR	3,803	:	5,000		FEDR	BUILDING 4 TR FEEDER	*	3			
3	*	AAA		FEDR		3,433	5,150		FEDR	AAA	*	3			
3	*	AAA		FEDR				3,333	5,000		*	3			
3	*	AAA	BUILDING 5 TR FEEDER	FEDR	1,767	:	1,767		FEDR	BUILDING 6 TR FEEDER	*	3			
3	*	AAA		FEDR		1,717	1,717		FEDR	AAA	*	3			
3	*	AAA		FEDR				1,667	: 1,667		*	3			
3	*	AAA	BUILDING 6 TR FEEDER	FEDR	1,767	:	1,817		FEDR	BUILDING 11 TR FEEDER	*	3			
3	*	AAA		FEDR		1,717	1,717		FEDR	AAA	*	3			
3	*	AAA		FEDR				1,667	: 1,667		*	3			
3	*	AAA	BUILDING 7 TR FEEDER	FEDR	1,767	:			FEDR	AAA	*	3			
3	*	AAA		FEDR		1,717	:								
3	*	AAA		FEDR				1,667	:						
3	*	AAA		FEDR											
TOTAL V-A					28,831		27,417	26,667			82,914	VA			
TOTAL AMPS					240		228	222			230	A			
AIC RATING: 22,000															
CONNECTED LOAD IN KVA (THIS PANEL: CONNECTED LOAD IN KVA (BRANCH PANELS): TOTAL CONNECTED LOAD IN KVA: DEMAND LOAD IN KVA:				LTG	RECP	MOTR	LG.MT	MISC	KIT	HEAT	SPEC	TOTAL	AMPS		
				0.00	0.00	0.00	0.00	0.00	0.00	0.00	0.00	0.0 KVA	0	A	
				2.16	0.00	0.00	0.00	80.75	0.00	0.00	0.00	82.9 KVA	230	A	
				2.16	0.00	0.00	0.00	80.75	0.00	0.00	0.00	82.9 KVA	230	A	
				2.71	0.00	0.00	0.00	80.75	0.00	0.00	0.00	83.5 KVA	232	A	

PANEL NOTES: PANEL OPTIONS:
MAIN LUGS ONLY

* SEE ONE-LINE DIAGRAM 1/EK-101

PANEL '4-EQB-T1'

MFR/MODEL: SQUARE 'D' TYPE NQ

VOLTS: 120/208V,3PH,4W

ENCLOSURE: NEMA 1

100 A

NOTE	CIRC	POLE	AMPS	SERVICE	TYPE	VOLT-AMPS			MTG. SURFACE	SERVICE			AMPS	POLE	CIRC	NOTE
						A	B	C								
	1	3	20	RK-04-1A	MISC	1,667							20	1	2	
	3	3	20	AAA	MISC		1,667	50					15	1	4	
	5	3	20	AAA	MISC								20	1	6	
	7	1	-	SPACE				1,667					-	1	8	
	9	1	-	SPACE									-	1	10	
	11	1	-	SPACE									-	1	12	
	13	1	-	SPACE									-	1	14	
	15	1	-	SPACE									-	1	16	
	17	1	-	SPACE									-	1	18	
	19	1	-	SPACE									-	1	20	
TOTAL V-A						1,667	1,717	1,667				5,050	VA			
TOTAL AMPS						14	14	14				14	A			
A.I.C. RATING: 10,000																
						LTG	RECIP	MOTR	LG MT	MISC	KIT	HEAT	SPEC	TOTAL	AMPS	
CONNECTED LOAD IN KVA (THIS PANEL):						0.00	0.00	0.00	0.00	0.00	0.00	0.00	0.00	5.1 KVA	14	A
CONNECTED LOAD IN KVA (BRANCH PANELS):														0.0 KVA	0	A
TOTAL CONNECTED LOAD IN KVA:						0.00	0.00	0.00	0.00	5.05	0.00	0.00	0.00	5.1 KVA	14	A
DEMAND LOAD IN KVA:						0.00	0.00	0.00	0.00	5.05	0.00	0.00	0.00	5.1 KVA	14	A

PANEL NOTES:

a FED FROM PANEL '2-EQDB-2'.

PANEL OPTIONS:

MAIN CIRCUIT BREAKER (SEE ONE-LINE FOR SIZE)

PANEL '4-EQ2-T1'

MFR/MODEL: SQUARE 'D' TYPE NO

VOLTS: 120/208V,3PH,4W

ENCLOSURE: NEMA 1

100 A

NOTE	CIRC	POLE	AMPS	SERVICE	TYPE	VOLT-AMPS			TYPE	MTG: SURFACE			AMPS	POLE	CIRC	NOTE	
						A	B	C		SERVICE							
	1	3	20	RK-203-1A	MISC	1,667							20	1	2		
	3	3	20	AAA	MISC		1,667	50					15	1	4		
	5	3	20	AAA	MISC					1,667			20	1	6		
	7	1	-	SPACE										1	8		
	9	1	-	SPACE										1	10		
	11	1	-	SPACE										1	12		
	13	1	-	SPACE										1	14		
	15	1	-	SPACE										1	16		
	17	1	-	SPACE										1	18		
	19	1	-	SPACE										1	20		
TOTAL V-A						1,667	1,717	1,667					5,050	VA			
TOTAL AMPS						14	14	14					14	A			
A.I.C. RATING: 10,000																	
CONNECTED LOAD IN KVA (THIS PANEL): CONNECTED LOAD IN KVA (BRANCH PANELS): TOTAL CONNECTED LOAD IN KVA: DEMAND LOAD IN KVA:						LTG	RECP	MOTR	LG.MT	MISC	KIT	HEAT	SPEC	TOTAL		AMPS	
						0.00	0.00	0.00	0.00	0.00	5.05	0.00	0.00	5.1 KVA		14	A
						0.00	0.00	0.00	0.00	5.05	0.00	0.00	0.00	0.0 KVA		0	A
						0.00	0.00	0.00	0.00	5.05	0.00	0.00	0.00	5.1 KVA		14	A
														5.1 KVA		14	A

PANEL NOTES:
a FED FROM PANEL '2-EQ0B-2'.

PANEL OPTIONS:
MAIN CIRCUIT BREAKER (SEE ONE-LINE FOR SIZE)

PANEL '3-EQ1-T1'										MFR/MODEL: SQUARE 'D' TYPE NQ										VOLTS: 120/208V,3PH,4W										ENCLOSURE: NEMA 1										100 A									
NOTE		CIRC	POLE	AMPS	SERVICE		TYPE	VOLT-AMPS		TYPE		MTG. SURFACE		SERVICE		AMPS	POLE	CIRC	NOTE																														
	1	3	30	RK-103-1A		MISC	3.333	A	200	B		C		LTG	TELECOM RM LTG		20	1	2																														
	3	3	30	AAA		MISC				3.333	50			MISC	3-DDC-1		15	1	4																														
	5	3	30	AAA		MISC						3.333			SPARE		20	1	6																														
	7	1	20	SPARE											SPARE		20	1	8																														
	9	1	-	SPACE											SPACE		-	1	10																														
	11	1	-	SPACE											SPACE		-	1	12																														
	13	1	-	SPACE											SPACE		-	1	14																														
	15	1	-	SPACE											SPACE		-	1	16																														
	17	1	-	SPACE											SPACE		-	1	18																														
	19	1	-	SPACE											SPACE		-	1	20																														
TOTAL V-A									3.533		3.383		3.333				10.250	VA																															
TOTAL AMPS									29		28		28				28	A																															
A.I.C. RATING: 10,000																																																	
CONNECTED LOAD IN KVA (THIS PANEL): CONNECTED LOAD IN KVA (BRANCH PANELS): TOTAL CONNECTED LOAD IN KVA: DEMAND LOAD IN KVA:										LTG	REC'D	MOT'R	LG MT	MISC	KIT	HEAT	SPEC	TOTAL	AMPS																														
										0.20	0.00	0.00	0.00	10.05	0.00	0.00	0.00	10.3 KVA	28	A																													
										0.20	0.00	0.00	0.00	10.05	0.00	0.00	0.00	0.0 KVA	0	A																													
										0.25	0.00	0.00	0.00	10.05	0.00	0.00	0.00	10.3 KVA	28	A																													
PANEL NOTES: a FED FROM PANEL 2-EQ0B-Z.										PANEL OPTIONS: MAIN CIRCUIT BREAKER (SEE ONE-LINE FOR SIZE)																																							
										0.25	0.00	0.00	0.00	10.05	0.00	0.00	0.00	10.3 KVA	29	A																													

PANEL '3-N1-T1'

MFR/MODEL: SQUARE 'D' TYPE NQ

VOLTS: 120/208V,3PH,4W

ENCLOSURE: NEMA 1

100 A

NOTE	CIRC	POLE	AMPS	SERVICE	TYPE	A	B	C	TYPE	SERVICE	AMPS	POLE	CIRC	NOTE	
	1	3	30	RK-103-1B	MISC	3,333				SPARE	20	1	2		
	3	3	30	***	MISC		3,333	720		TR EAST RECP	20	1	4		
	5	3	30	***	MISC			3,333	720	RECP	20	1	6		
	7	2	40	3-UJ-1	MOTR	3,120	180			TR WEST RECP	20	1	8		
	9	2	40	JA	MOTR		3,120			EXTERIOR RECP 3-CU-1	20	1	10		
	11	2	40	3-CU-1	MOTR			2,132		SPARE	20	1	12		
	13	2	40	JA	MOTR	2,132				SPARE	20	1	14		
	15	1	20	SPACE						SPARE	20	1	16		
	17	1	20	SPACE						SPARE	20	1	18		
	19	1	-	SPACE						SPACE	-	1	20		
	21	1	-	SPACE						SPACE	-	1	22		
	23	1	-	SPACE						SPACE	-	1	24		
	25	1	-	SPACE						SPACE	-	1	26		
	27	1	-	SPACE						SPACE	-	1	28		
	29	1	-	SPACE						SPACE	-	1	30		
TOTAL V-A						8,765	7,173	6,185	22,124 VA						
TOTAL AMPS						73	60	52	61 A						
A.I.C. RATING: 10,000															
						LTG	RECP	MOTR	LG MT	MISC	KIT	HEAT	SPEC	TOTAL	AMPS
CONNECTED LOAD IN KVA (THIS PANEL)						0.00	1.62	10.50	1.56	10.00	0.00	0.00	0.00	22.1 KVA	61 A
CONNECTED LOAD IN KVA (BRANCH PANELS)														0.0 KVA	0 A
TOTAL CONNECTED LOAD IN KVA						0.00	1.62	10.50	1.56	10.00	0.00	0.00	0.00	22.1 KVA	61 A
DEMAND LOAD IN KVA						0.00	1.62	10.50	1.56	10.00	0.00	0.00	0.00	23.7 KVA	66 A
PANEL NOTES:															
a FED FROM DOM COMPLEX MAIN SWITCHBOARD NORMAL SECTION VIA SOUTH BUS DUCT.															
PANEL OPTIONS:															
MAIN CIRCUIT BREAKER (SEE ONE-LINE FOR SIZE)															

PANEL '4-EQ1-T1'																
MFR/MODEL: SQUARE D TYPE NQ						VOLTS: 120/208V 3PH,4W				ENCLOSURE: NEMA 1				100 A		
NOTE		CIRC	POLE	AMPS	SERVICE	TYPE	VOLT-AMPS			MTG: SURFACE						
							A	B	C	TYPE	SERVICE	AMPS	POLE	CIRC	NOTE	
	1	3	20	RK-103-1A	MISC	1,667					SPARE	20	1	2		
	3	3	20	AM	MISC		1,667	50			4,DDC-2	15	1	4		
	5	3	20	AM	MISC				1,667		SPARE	20	1	6		
	7	1	-	SPACE							SPACE	-	1	8		
	9	1	-	SPACE							SPACE	-	1	10		
	11	1	-	SPACE							SPACE	-	1	12		
	13	1	-	SPACE							SPACE	-	1	14		
	15	1	-	SPACE							SPACE	-	1	16		
	17	1	-	SPACE							SPACE	-	1	18		
	19	1	-	SPACE							SPACE	-	1	20		
TOTAL V/A							1,667	1,717	1,667			5,050	VA			
TOTAL AMPS							14	14	14			14	A			
A.I.C. RATING: 10,000																
CONNECTED LOAD IN KVA (THIS PANEL): CONNECTED LOAD IN KVA (BRANCH PANELS): TOTAL CONNECTED LOAD IN KVA: DEMAND LOAD IN KVA:						LTG	RECP	MOTR	LG.MT	MISC	KIT	HEAT	SPEC	TOTAL	AMPS	
						0.00	0.00	0.00	0.00	5.05	0.00	0.00	0.00	5.1 KVA	14	A
						0.00		0.00	0.00	5.05	0.00	0.00	0.00	0.0 KVA	0	A
						0.00	0.00	0.00	0.00	5.1 KVA	14	A				
PANEL NOTES: a FED FROM PANEL 2-EQ0B-Z.						PANEL OPTIONS: MAIN CIRCUIT BREAKER (SEE ONE-LINE FOR SIZE)										

[illegible]

CONSULTANT

A/E:
GDM
1000 W STEUBEN STR, UNIT 3
BINGEN, WA 98605
541.436.4723
ADAM GOODIN, PE

ARCHITECT/ENGINEER OF RECORD

RSA

Engineering, Inc.

MECHANICAL AND ELECTRICAL CONSULTING ENGINEERS
670 West Fireweed Lane, Suite 200
Anchorage, AK 99503
Phone (907) 276-0521
Corporate No.: AECC542

A circular professional engineer stamp for the State of Alaska. The outer ring contains the text "STATE OF ALASKA" at the top and "REGISTERED PROFESSIONAL ENGINEER" at the bottom, separated by a dashed line. Inside the ring, the text "40TH" is written above a star. Below the star, the name "JEREMY A. MAXIE" is printed, followed by the license number "EE-113847" and the expiration date "3/31/20".

**PROGRAM
CONTRACTING
ACTIVITY
CENTRAL (PCAC)**

VA U.S. Department
of Veterans Affairs

DRAWING TITLE

BUILDING 2, 3 & 4 - PANEL
SCHEDULES

APPROVED: Project Director

PHASE	100% CD FINAL SOLUTION
FLS	FULLY SPRINKLERED

PROJECT TITLE		
EHRM INFRASTRUCTURE UPGRADES		
LOCATION		
HOT SPRINGS, SOUTH DAKOTA		
ISSUE DATE	CHECKED BY	DRAWN BY
02/22/2022	JAM	CSZ

PROJECT NUMBER
568A4-21-702
BUILDING NUMBER
N/A
DRAWING NUMBER
EK-107

A

B

C

D

E

F

3/14/2022 10:09:02 AM

C:\Users\Caleb\AppData\Local\Microsoft\Windows\CurrentVersion\Explorer\History\History.IE5\history

T

EXISTING PANEL '4-NB-1'															
MFR/MODEL: EATON PRL1A				VOLTS: 120/208V,3PH,4W				ENCLOSURE: NEMA 1				225 A			
NOTE	CIRC	POLE	AMPS	SERVICE	TYPE	A	B	C	MTG: SURFACE	SERVICE	AMPS	POLE	CIRC	NOTE	
a	1	1	20	ELEVATOR EQUIPMENT						VENDING MACHINE	20	1	2	a	
a	3	1	20	ELEVATOR PIT RECP						VENDING MACHINE	20	1	4	a	
a	5	1	20	ELEVATOR CAB						VENDING MACHINE	20	1	6	a	
a	7	1	20	COMPUTER RACK		1,667			MISC	RK-44-1B	20	3	8	b	
a	9	1	20	COMPUTER RACK			1,667		MISC	AAA	20	3	10	b	
a	11	1	20	SPARE				1,667	MISC	4-CU-1	40	2	14	b	
a	13	1	20	SPARE		2,132			MOTR	AA	40	2	16	b	
a	15	1	20	SPARE			2,132		MOTR	4-IU-1	40	2	18	b	
a	17	1	20	SPARE				3,120	MOTR	AA	40	2	20	b	
a	19	1	20	SPARE		3,120			RECP	EXTERIOR RECP 4-CU-1	20	1	22	b	
a	21	1	20	RECP FOR MINI-SPLIT COND PMP			190		SPARE		15	1	24	b	
a	23	1	20	SPARE					SPARE		20	1	26		
a	25	1	20	SPARE					SPARE		20	1	28		
a	27	2	15	A/C SPLIT UNIT HEAD (RM 4)					SPARE		20	1	30		
a	29	2	15	AA					SPARE		20	1	32		
a	31	3	35	OUTSIDE CONDENSING UNIT					SPARE		20	1	34		
a	33	3	35	AA					SPARE		20	1	36		
a	35	3	35	AA					SPARE		20	1	38		
a	37	3	15	POWER METER					SPACE		-	1	40		
a	39	3	15	AA					SPACE		-	1	42		
a	41	3	15	AA					SPACE		-	1	42		
TOTAL V-A						6,919		3,979	4,787		15,684	VA			
TOTAL AMPS						58		33	40		44	A			
A.I.C. RATING: 22,000															
CONNECTED LOAD IN KVA (THIS PANEL):						LTG	RECP	MOTR	LG.MT	MISC	KIT	HEAT	SPEC	TOTAL	AMPS
CONNECTED LOAD IN KVA (BRANCH PANELS):						0.00	0.18	10.50	1.56	5.00	0.00	0.00	0.00	15.7 KVA	44 A
TOTAL CONNECTED LOAD IN KVA:						0.00	0.18	10.50	1.56	5.00	0.00	0.00	0.00	15.7 KVA	44 A
DEMAND LOAD IN KVA:						0.00	0.18	10.50	1.56	5.00	0.00	0.00	0.00	17.2 KVA	48 A
PANEL NOTES:									PANEL OPTIONS:						
a EXISTING LOAD.									MAIN CIRCUIT BREAKER (SEE ONE-LINE FOR SIZE)						
b INSTALL NEW CIRCUIT BREAKER IN SPACE AVAILABLE IN THE PANEL. THE NEW CIRCUIT BREAKER SHALL BE COMPATIBLE WITH AND LISTED FOR USE IN THE PANEL.															

EXISTING (E) PANEL '4-N1-1'															
MFR/MODEL: SQUARE 'D' TYPE NQ				VOLTS: 120/208V,3PH,4W				ENCLOSURE: NEMA 1				100 A			
NOTE	CIRC	POLE	AMPS	SERVICE	TYPE	A	B	C	MTG: SURFACE	SERVICE	AMPS	POLE	CIRC	NOTE	
a	1	1	20	RECP NORTH						GFOI RECP BATHROOM	20	1	2	a	
a	3	1	20	RECP NORTH						LTG LOBBY	20	1	4	a	
a	5	1	20	RECP NORTH						LTG BATHROOM	20	1	6	a	
a	7	1	20	RECP NORTH						ICE MACHINE	20	1	8	a	
a	9	1	20	DOOR OPENER LOWER ARCADE						SPARE	20	1	10	a	
a	11	1	20	DOOR OPENER LOWER ARCADE						SPARE	20	1	12	a	
a	13	1	20	RECP DATA RACK						SPARE	20	1	14	a	
a	15	1	20	RECP DATA RACK						POWER METER	15	3	16	a	
a	17	1	20	JOHNSON CONTROL EQUIPMENT					AAA		15	3	18	a	
b	19	2	40	4-CU-2	MOTR	2,132			AAA		15	3	20	a	
b	21	2	40	AA	MOTR		2,132		AAA		15	2	22	a	
b	23	2	40	4-IU-2	MOTR			3,120	AA		15	2	24	a	
b	25	2	40	AA	MOTR	3,120			AA		-	1	26		
a	27	1	20	SPACE					AA		-	1	28		
a	29	1	-	SPACE					AA		-	1	30		
TOTAL V-A						5,252		2,132	3,120		10,504	VA			
TOTAL AMPS						44		18	26		29	A			
A.I.C. RATING: 22,000															
CONNECTED LOAD IN KVA (THIS PANEL):						LTG	RECP	MOTR	LG.MT	MISC	KIT	HEAT	SPEC	TOTAL	AMPS
CONNECTED LOAD IN KVA (BRANCH PANELS):						0.00	0.00	10.50	1.56	0.00	0.00	0.00	0.00	10.5 KVA	29 A
TOTAL CONNECTED LOAD IN KVA:						0.00	0.00	10.50	1.56	0.00	0.00	0.00	0.00	10.5 KVA	29 A
DEMAND LOAD IN KVA:						0.00	0.00	10.50	1.56	0.00	0.00	0.00	0.00	12.1 KVA	33 A
PANEL NOTES:									PANEL OPTIONS:						
a EXISTING LOAD									MAIN CIRCUIT BREAKER (SEE ONE-LINE FOR SIZE)						
b INSTALL NEW CIRCUIT BREAKER IN SPACE AVAILABLE IN THE PANEL. THE NEW CIRCUIT BREAKER SHALL BE COMPATIBLE WITH AND LISTED FOR USE IN THE PANEL.															

EXISTING (E) PANEL '4-N2-2'															
MFR/MODEL: EATON				VOLTS: 120/208V,3PH,4W				ENCLOSURE: NEMA 1				225 A			
NOTE	CIRC	POLE	AMPS	SERVICE	TYPE	A	B	C	MTG: SURFACE	SERVICE	AMPS	POLE	CIRC	NOTE	
a	1	1	20	LTG 205A NORTH SIDE						LTG 205A SOUTH SIDE	20	1	2	a	
a	3	1	20	LTG 204, 205, 206, 206A, 207						LTG 205B	20	1	4	a	
a	5	1	20	LTG 202, 203						RECP 205B	20	1	6	a	
a	7	1	20	RECP 209, 210						FURNITURE 204, 205	20	1	8	a	
a	9	1	20	SPARE						FURNITURE 206, 207	20	1	10	a	
a	11	1	20	LTG 208, 209, 210		1,667		1,667	MISC	RK-203-1B	30	3	12	b	
a	13	1	20	FURNITURE DOUBLE 205A					MISC	AAA	30	3	14	b	
a	15	2	20	FURNITURE QUAD 205A					MISC	AAA	30	3	16	b	
a	17	2	20	AA					SPARE		20	1	18	b	
a	19	1	20	FURNITURE DOUBLE 205A						FURNITURE DOUBLE	20	1	20	a	
a	21	1	20	FURNITURE DOUBLE 205A						FURNITURE QUAD	20	2	22	a	
a	23	2	20	FURNITURE QUAD 205A						AA	20	2	24	a	
a	25	2	20	AA						FURNITURE QUAD	20	2	26	a	
a	27	2	20	FURNITURE QUAD 205A						AA	20	2	28	a	
a	29	2	20	AA						FURNITURE QUAD	20	2	30	a	
a	31	1	20	WATER FOUNTAIN						AA	20	2	32	a	
a	33	1	20	SPARE						FURNITURE DOUBLE	20	1	34	a	
a	35	1	20	SPARE						FURNITURE DOUBLE	20	1	36	a	
a	37	3	15	ELECTRIC METERING						WATER HEATER	30	1	38	a	
a	39	3	15	AA						SPARE	20	1	40		
a	41	3	15	AA						SPACE	20	1	42		
TOTAL V-A						1,667		1,667	1,667		5,000	VA			
TOTAL AMPS						14		14	14		14	A			
A.I.C. RATING: 22,000															
CONNECTED LOAD IN KVA (THIS PANEL):						LTG	RECP	MOTR	LG.MT	MISC	KIT	HEAT	SPEC	TOTAL	AMPS
CONNECTED LOAD IN KVA (BRANCH PANELS):						0.00	0.00	0.00	0.00	5.00	0.00	0.00	0.00	5.0 KVA	14 A
TOTAL CONNECTED LOAD IN KVA:						0.00	0.00	0.00	0.00	5.00	0.00	0.00	0.00	5.0 KVA	14 A
DEMAND LOAD IN KVA:						0.00	0.00	0.00	0.00	5.00	0.00	0.00	0.00	5.0 KVA	14 A
PANEL NOTES:									PANEL OPTIONS:						
a EXISTING LOAD									MAIN CIRCUIT BREAKER (SEE ONE-LINE FOR SIZE)						
b INSTALL NEW CIRCUIT BREAKER IN SPACE AVAILABLE IN THE PANEL. THE NEW CIRCUIT BREAKER SHALL BE COMPATIBLE WITH AND LISTED FOR USE IN THE PANEL.															

EXISTING PANEL '4-NB-2'																		
MFR/MODEL: EATON PRL1A						VOLTS: 120/208V,3PH,4W			ENCLOSURE: NEMA 1				225 A					
						VOLT-AMPS			MTG: SURFACE									
NOTE	CIRC	POLE	AMPS	SERVICE	TYPE	A	B	C	TYPE	SERVICE	AMPS	POLE	CIRC	NOTE				
a	1	1	20	LTG RM 16,17,20						LTG RM 5	20	1	2	a				
a	3	1	20	LTG RM 11,12						LTG RM 9	20	1	4	a				
a	5	1	20	TABLE RECP RM 8						WALL RECP RM 1	20	1	6	a				
a	7	1	20	RECP RM 11						TABLE RECP RM 8	20	1	8	a				
a	9	1	20	RECP RM 12						RECP RM 100	20	1	10	a				
a	11	1	20	TABLE RECP RM 8						RECP RM 100	20	1	12	a				
a	13	1	20	RECP RM 9						TABLE RECP RM 8	20	1	14	a				
a	15	1	20	RECP RM 16,17,20						TABLE RECP RM 8	20	1	16	a				
a	17	1	20	WALL RECP RM 5						TABLE RECP RM 8	20	1	18	a				
a	19	1	20	WALL RECP RM 5						HALLWAY RECP	20	1	20	a				
a	21	1	20	WALL RECP RM 5						LTG RM 11,12	20	1	22	a				
a	23	1	20	WALL RECP RM 5						SPARE	20	1	24	b				
a	25	1	20	WALL RECP RM 5						SPARE	20	1	26	b				
a	27	1	20	WALL RECP RM 5						SPARE	20	1	28	b				
a	29	1	20	SPARE						SPARE	20	1	30	b				
a	31	1	20	WATER METER						POWER METER	15	3	32	a				
a	33	1	20	LANDING LTG						AAA	15	3	34	a				
a	35	1	20	SPARE						AAA	15	3	36	a				
a	37	1	20	ADO NEAR EAST OUTSIDE DOOR						WATER FOUNTAIN	20	1	38	a				
a	39	20		ELECTRIC/DATA RM LTG, RECP						SPARE	20	1	40					
a	41	1	20	SPARE						SPARE	20	1	42					
TOTAL V-A						0	0	0	0 VA									
TOTAL AMPS						0	0	0	0 A									
A.I.C. RATING: 22,000																		
CONNECTED LOAD IN KVA (THIS PANEL):									LTG	RECP	MOTR	LG.MT	MISC	KIT	HEAT	SPEC	TOTAL	AMPS
CONNECTED LOAD IN KVA (BRANCH PANELS):									0.00	0.00	0.00	0.00	0.00	0.00	0.00	0.00	0.0 KVA	0 A
TOTAL CONNECTED LOAD IN KVA:									0.00	0.00	0.00	0.00	0.00	0.00	0.00	0.00	0.0 KVA	0 A
DEMAND LOAD IN KVA:									0.00	0.00	0.00	0.00	0.00	0.00	0.00	0.00	0.0 KVA	0 A
PANEL NOTES:																		
a EXISTING LOAD.																		
b INSTALL NEW CIRCUIT BREAKER IN SPACE AVAILABLE IN THE PANEL. THE NEW CIRCUIT BREAKER SHALL BE COMPATIBLE WITH AND LISTED FOR USE IN THE PANEL.																		
PANEL OPTIONS:																		
MAIN CIRCUIT BREAKER (SEE ONE-LINE FOR SIZE)																		

C:\Users\Caleb\AppData\Local\Microsoft\Windows\Temporary Internet Files\Content.IE5\B342Q222\10-09-05-AM

E

F

VA FORM 08 - 6231

PANEL '5-EQ2-T1'																
MFR/MODEL: SQUARE 'D' TYPE NQ						VOLTS: 120/208V,3PH,4W				ENCLOSURE: NEMA 1				100 A		
NOTE	CIRC	POLE	AMPS	SERVICE	TYPE	VOLT-AMPS			MTG. SURFACE				AMPS	POLE	CIRC	NOTE
						A	B	C	TYPE	SERVICE						
	1	3	20	RK-211-1A	MISC	1,667	100	50	1,667	LTG	TELECOM RM LTG	20	1	2		
	3	3	20	AAA	MISC					5-DDC-1	15	1	4			
	5	3	20	AAA	MISC					SPARE	20	1	6			
	7	1	-	SPACE						SPACE	-	1	8			
	9	1	-	SPACE						SPACE	-	1	10			
	11	1	-	SPACE						SPACE	-	1	12			
	13	1	-	SPACE						SPACE	-	1	14			
	15	1	-	SPACE						SPACE	-	1	16			
	17	1	-	SPACE						SPACE	-	1	18			
	19	1	-	SPACE						SPACE	-	1	20			
TOTAL V-A						1,767	1,717	1,667	5,150 VA							
TOTAL AMPS						15	14	14	14 A							
A.I.C. RATING: 10,000																
CONNECTED LOAD IN KVA (THIS PANEL):						LTG	RECP	MOTR	LG MT	MISC	KIT	HEAT	SPEC	TOTAL	AMPS	
CONNECTED LOAD IN KVA (BRANCH PANELS):						0.10	0.00	0.00	0.00	5.05	0.00	0.00	0.00	5.2 KVA	14	A
TOTAL CONNECTED LOAD IN KVA:						0.10	0.00	0.00	0.00	5.05	0.00	0.00	0.00	0.0 KVA	0	A
DEMAND LOAD IN KVA:						0.13	0.00	0.00	0.00	5.05	0.00	0.00	0.00	5.2 KVA	14	A
PANEL NOTES:																
a FED FROM PANEL '2-EQDB-2'.																
PANEL OPTIONS:																
MAIN CIRCUIT BREAKER (SEE ONE-LINE FOR SIZE)																

PANEL '6-EQ1-T1'																
MFR/MODEL: SQUARE 'D' TYPE NQ						VOLTS: 120/208V,3PH,4W			ENCLOSURE: NEMA 1			100 A				
NOTE	CIRC	POLE	AMPS	SERVICE	TYPE	VOLT-AMPS			MTG. SURFACE			AMPS	POLE	CIRC	NOTE	
						A	B	C	TYPE	SERVICE						
1	3	20	RK-102-1A		MISC	1,667	100		LTG	TELECOM RM LTG	20	1	2			
3	3	20	AAA		MISC			1,667	50		6-DDC-1	15	1	4		
5	3	20	AAA		MISC					1,667		20	1	6		
7	1	20	SPARE								SPARE	20	1	8		
9	1	-	SPACE								SPACE	-	1	10		
11	1	-	SPACE								SPACE	-	1	12		
13	1	-	SPACE								SPACE	-	1	14		
15	1	-	SPACE								SPACE	-	1	16		
17	1	-	SPACE								SPACE	-	1	18		
19	1	-	SPACE								SPACE	-	1	20		
TOTAL V-A						1,767		1,717		1,667		5,150	VA			
TOTAL AMPS						15		14		14		14	A			
A.I.C. RATING: 10,000																
CONNECTED LOAD IN KVA (THIS PANEL): CONNECTED LOAD IN KVA (BRANCH PANELS): TOTAL CONNECTED LOAD IN KVA: DEMAND LOAD IN KVA:						LTG	RECP	MOTR	LG.MT	MISC	KIT	HEAT	SPEC	TOTAL	AMPS	
						0.10	0.00	0.00	0.00	5.05	0.00	0.00	0.00	5.2 KVA	14	A
						0.10	0.00	0.00	0.00	5.05	0.00	0.00	0.00	0.0 KVA	0	A
						0.13	0.00	0.00	0.00	5.05	0.00	0.00	0.00	5.2 KVA	14	A
PANEL NOTES: a FED FROM PANEL '2-EQDB-2'.																
PANEL OPTIONS: MAIN CIRCUIT BREAKER (SEE ONE-LINE FOR SIZE)																

PANEL '7-EQ1-T1'																	
MFR/MODEL: SQUARE 'D' TYPE NQ						VOLTS: 120/208V,3PH,4W			ENCLOSURE: NEMA 1			100 A					
NOTE	CIRC	POLE	AMPS	SERVICE	TYPE	VOLT-AMPS			MTG. SURFACE			AMPS	POLE	CIRC	NOTE		
						A	B	C	TYPE	SERVICE							
	1	3	20	RK-110-1A	MISC	1,667	100		LTG	TELECOM RM 110 LTG	20	1	2				
	3	3	20	AAA	MISC			1,667	50		7-DDC-1	15	1	4			
	5	3	20	AAA	MISC					1,667		20	1	6			
	7	1	-	SPACE							SPACE	-	1	8			
	9	1	-	SPACE							SPACE	-	1	10			
	11	1	-	SPACE							SPACE	-	1	12			
	13	1	-	SPACE							SPACE	-	1	14			
	15	1	-	SPACE							SPACE	-	1	16			
	17	1	-	SPACE							SPACE	-	1	18			
	19	1	-	SPACE							SPACE	-	1	20			
TOTAL V-A						1,767		1,717		1,667		5,150	VA				
TOTAL AMPS						15		14		14		14	A				
A.I.C. RATING: 10,000																	
CONNECTED LOAD IN KVA (THIS PANEL): CONNECTED LOAD IN KVA (BRANCH PANELS): TOTAL CONNECTED LOAD IN KVA: DEMAND LOAD IN KVA:						LTG	RECP	MOTR	LG.MT	MISC	KIT	HEAT	SPEC	TOTAL		AMPS	
						0.10	0.00	0.00	0.00	5.05	0.00	0.00	0.00	5.2 KVA		14 A	
						0.10	0.00	0.00	0.00	5.05	0.00	0.00	0.00	0.0 KVA		0 A	
						0.10	0.00	0.00	0.00	5.05	0.00	0.00	0.00	5.2 KVA		14 A	
PANEL NOTES: a FED FROM PANEL '2-EQDB-2'.						0.13	0.00	0.00	0.00	5.05	0.00	0.00	0.00	5.2 KVA		14 A	
						PANEL OPTIONS: MAIN CIRCUIT BREAKER (SEE ONE-LINE FOR SIZE)											

PANEL '5-N2-T1'																
MFR/MODEL: SQUARE 'D' TYPE NQ						VOLTS: 120/208V,3PH,4W			ENCLOSURE: NEMA 1			100 A				
NOTE	CIRC	POLE	AMPS	SERVICE	TYPE	VOLT-AMPS			MTG. SURFACE			AMPS	POLE	CIRC	NOTE	
						A	B	C	TYPE	SERVICE						
	1	3	20	RK-211-1B	MISC	1,667					SPARE	20	1	2		
	3	3	20	AAA	MISC		1,667	720			RECP	20	1	4		
	5	3	20	AAA	MISC				1,667	720	RECP	20	1	6		
	7	2	45	5-IU-1	MOTR	3,557					SPARE	20	1	8		
	9	2	45	5-IU-1	MOTR		3,557				SPARE	20	1	10		
	11	2	40	5-CU-1	MOTR				2,164		SPARE	20	1	12		
	13	2	40	5-CU-1	MOTR	2,164					SPARE	20	1	14		
	15	1	20	SPARE							SPARE	20	1	16		
	17	1	20	SPARE							SPARE	20	1	18		
	19	1	-	SPACE							SPACE	-	1	20		
	21	1	-	SPACE							SPACE	-	1	22		
	23	1	-	SPACE							SPACE	-	1	24		
	25	1	-	SPACE							SPACE	-	1	26		
	27	1	-	SPACE							SPACE	-	1	28		
	29	1	-	SPACE							SPACE	-	1	30		
TOTAL V-A						7,388	5,944	4,551				17,882	VA			
TOTAL AMPS						62	50	38				50	A			
A.I.C. RATING: 10,000																
						LTG	RECP	MOTR	LG MT	MISC	KIT	HEAT	SPEC	TOTAL	AMPS	
CONNECTED LOAD IN KVA (THIS PANEL):						0.00	1.44	11.44	1.78	5.00	0.00	0.00	0.00	17.9 KVA	50	A
CONNECTED LOAD IN KVA (BRANCH PANELS):													0.0 KVA	0	A	
TOTAL CONNECTED LOAD IN KVA:						0.00	1.44	11.44	1.78	5.00	0.00	0.00	17.9 KVA	50	A	
DEMAND LOAD IN KVA:						0.00	1.44	11.44	1.78	5.00	0.00	0.00	19.7 KVA	55	A	
PANEL NOTES:																
a FED FROM DOM COMPLEX MAIN SWITCHBOARD NORMAL SECTION VIA SOUTH BUS DUCT.																
PANEL OPTIONS:																
MAIN CIRCUIT BREAKER (SEE ONE-LINE FOR SIZE)																

B

B

C

C

D

E**F****E**

D

C

E**F**

PANEL 'BE-NT1'																
MFR/MODEL: SQUARE 'D' TYPE NQ						VOLTS: 120/208V,3PH,4W				ENCLOSURE: NEMA 1				100 A		
NOTE	CIRC	POLE	AMPS	SERVICE	TYPE	VOLT-AMPS			MTG. SURFACE							
						A	B	C	TYPE	SERVICE	AMPS	POLE	CIRC	NOTE		
	1	3	30	RK-AB06-1B		MISC	3,333	:	:			SPARE	20	1	2	
	3	3	30	AAA		MISC		3,333	:	:		SPARE	20	1	4	
	5	3	30	AAA		MISC				3,333	:	SPARE	20	1	6	
	7	1	20	SPARE			:	:	:			SPARE	20	1	8	
	9	1	20	SPARE			:	:	:			SPARE	20	1	10	
	11	1	20	SPARE			:	:	:			SPARE	20	1	12	
	13	1	20	SPARE			:	:	:			SPARE	20	1	14	
	15	1	-	SPACE			:	:	:			SPARE	20	1	16	
	17	1	-	SPACE			:	:	:			SPARE	20	1	18	
	19	1	-	SPACE			:	:	:			SPACE	-	1	20	
	21	1	-	SPACE			:	:	:			SPACE	-	1	22	
	23	1	-	SPACE			:	:	:			SPACE	-	1	24	
	25	1	-	SPACE			:	:	:			SPACE	-	1	26	
	27	1	-	SPACE			:	:	:			SPACE	-	1	28	
	29	1	-	SPACE			:	:	:			SPACE	-	1	30	
TOTAL V-A							3,333		3,333		3,333		10,000	VA		
TOTAL AMPS							28		28		28		28	A		
A.I.C. RATING: 10,000																
						LTG	RECP	MOTR	LG MT	MISC	KIT	HEAT	SPEC	TOTAL	AMPS	
CONNECTED LOAD IN KVA (THIS PANEL):						0.00	0.00	0.00	0.00	10.00	0.00	0.00	0.00	10.0 KVA	28	A
CONNECTED LOAD IN KVA (BRANCH PANELS):						0.00	0.00	0.00	0.00	10.00	0.00	0.00	0.00	0.0 KVA	0	A
TOTAL CONNECTED LOAD IN KVA:						0.00	0.00	0.00	0.00	10.00	0.00	0.00	0.00	10.0 KVA	28	A
DEMAND LOAD IN KVA:						0.00	0.00	0.00	0.00	10.00	0.00	0.00	0.00	10.0 KVA	28	A
PANEL NOTES:																
a FED FROM PANEL '12-IDP2'.																
PANEL OPTIONS:																
MAIN CIRCUIT BREAKER (SEE ONE-LINE FOR SIZE)																

(E) PANEL 'BE-LS1'																				
MFR/MODEL: WESTINGHOUSE					VOLTS: 120/208V,3PH,4W					ENCLOSURE: NEMA 1					150 A					
NOTE	CIRC	POLE	AMPS	SERVICE	TYPE	VOLT-AMPS					MTG. SURFACE									
						A		B		C		TYPE		SERVICE		AMPS		POLE	CIRC	NOTE
b	1	3	30	RK-AB06-1A	MISC	3,333							SPARE			50	2	2		
b	3	3	30	AAA	MISC			3,333					AA			50	2	4		
b	5	3	30	AAA	MISC				3,333				SPARE			50	2	6		
a	7	1	20	RECP SOUTH WALL RM AB06	RECP	360							AA			50	2	8		
a	9	1	20	RECP SOUTH WALL RM AB06	RECP		360						SPARE			20	1	10		
a	11	1	20	RECP WEST WALL RM AB06	RECP				1,080				SPARE			20	1	12		
a	13	1	20	RECP WEST WALL RM AB06	RECP	1,080	240						MISC	TELEPHONE ALARM PANEL		20	1	14	a	
a	15	1	20	RECP NORTH WALL RM AB06	RECP		360	360					RECP	RECP WEST WALL RM AB06		20	1	16	a	
a	17	1	20	RECP NORTH WALL RM AB06	RECP				360				SPARE			20	1	18		
a	19	1	20	RECP EAST WALL RM AB06	RECP	720	360						RECP	RECP BELOW PANEL		20	1	20	a	
a	21	1	20	RECP EAST WALL RM AB06	RECP		360						SPARE			20	1	22		
a	23	1	20	RECP RM AB04	RECP				1,080				SPARE			20	1	24		
a	25	2	20	208V RECP EAST WALL RM AB06	RECP	1,664	360						RECP	RECP WEST AND EAST WALL RM AB06		20	1	26	a	
a	27	2	20	AA	RECP		1,664	2,496					MISC	TOP RECTIFIER UPS		30	2	28	a	
	29	2	30	SPARE						2,496			MISC	AA		30	2	30	a	
	31	2	30	AA			2,496						MISC	TOP RECTIFIER UPS		30	2	32	a	
	33	1	-	SPACE				2,496					MISC	AA		30	2	34	a	
	35	1	-	SPACE						2,496			MISC	TOP RECTIFIER UPS		30	2	36	a	
	37	1	-	SPACE			2,496						MISC	AA		30	2	38	a	
	39	1	-	SPACE									SPACE			-	1	40		
	41	1	-	SPACE									SPACE			-	1	42		
TOTAL V-A							13,109		11,429		10,845					35,384	VA			
TOTAL AMPS							109		95		90					98	A			
A.I.C. RATING: 10,000																				
						LTG	RECP	MOTR	LG.MT	MISC	KIT	HEAT	SPEC	TOTAL		AMPS				
CONNECTED LOAD IN KVA (THIS PANEL):						0.00	10.17	0.00	0.00	25.22	0.00	0.00	0.00	35.4 KVA		98 A				
CONNECTED LOAD IN KVA (BRANCH PANELS):						0.00	10.17	0.00	0.00	25.22	0.00	0.00	0.00	0.0 KVA		0 A				
TOTAL CONNECTED LOAD IN KVA:						0.00	10.17	0.00	0.00	25.22	0.00	0.00	0.00	35.4 KVA		98 A				
DEMAND LOAD IN KVA:						0.00	10.08	0.00	0.00	25.22	0.00	0.00	0.00	35.3 KVA		98 A				
PANEL NOTES:										PANEL OPTIONS:										
a LOAD SHOWN IS BASED ON LOAD SERVED.										MAIN CIRCUIT BREAKER (SEE ONE-LINE FOR SIZE)										
b INSTALL NEW CIRCUIT BREAKER IN SPACE AVAILABLE IN THE PANEL. THE NEW CIRCUIT BREAKER SHALL BE COMPATIBLE WITH AND LISTED FOR USE IN THE PANEL.																				

PANEL 'GE-EQT1'																	
MFR/MODEL: SQUARE 'D' TYPE NQ						VOLTS: 120/208V,3PH,4W				ENCLOSURE: NEMA 1				100 A			
NOTE	CIRC	POLE	AMPS	SERVICE	TYPE	VOLT-AMPS				MTG. SURFACE				AMPS	POLE	CIRC	NOTE
						A	B		C	TYPE	SERVICE						
1	3	20	RK-A038-1A		MISC	1,667	100			LTG	TELECOM RM A038 LTG	20	1	2			
3	3	20	AAA		MISC			1,667			SPARE	20	1	4			
5	3	20	AAA		MISC				1,667		SPARE	20	1	6			
7	1	-	SPACE								SPACE	-	1	8			
9	1	-	SPACE								SPACE	-	1	10			
11	1	-	SPACE								SPACE	-	1	12			
13	1	-	SPACE								SPACE	-	1	14			
15	1	-	SPACE								SPACE	-	1	16			
17	1	-	SPACE								SPACE	-	1	18			
19	1	-	SPACE								SPACE	-	1	20			
TOTAL V-A							1,767		1,667		1,667			5,100	VA		
TOTAL AMPS								15		14				14	A		
A.I.C. RATING: 10,000																	
						LTG	RECP	MOTR	LG.MT	MISC	KIT	HEAT	SPEC	TOTAL		AMPS	
CONNECTED LOAD IN KVA (THIS PANEL):						0.10	0.00	0.00	0.00	5.00	0.00	0.00	0.00	5.1 KVA		14	A
CONNECTED LOAD IN KVA (BRANCH PANELS):														0.0 KVA		0	A
TOTAL CONNECTED LOAD IN KVA:						0.10	0.00	0.00	0.00	5.00	0.00	0.00	0.00	5.1 KVA		14	A
DEMAND LOAD IN KVA:						0.13	0.00	0.00	0.00	5.00	0.00	0.00	0.00	5.1 KVA		14	A
PANEL NOTES: a FED FROM PANEL '12-EODP'.																	
PANEL OPTIONS: MAIN CIRCUIT BREAKER (SEE ONE-LINE FOR SIZE)																	

PANEL '1E-EQT1'																			
MFR/MODEL: SQUARE 'D' TYPE NQ					VOLTS: 120/208V,3PH,4W					ENCLOSURE: NEMA 1					100 A				
NOTE	CIRC	POLE	AMPS	SERVICE	TYPE	VOLT-AMPS			MTG: SURFACE		SERVICE	AMPS	POLE	CIRC	NOTE				
						A	B	C	TYPE	LTG									
1	3	30	AAA	RKA119-1A	MISC	3,333	150	3,333			TELECOM RM A119 LTG	20	1	2					
3	3	30	AAA		MISC						SPARE	20	1	4					
5	3	30	AAA		MISC			3,333			SPARE	20	1	6					
7	1	-		SPACE							SPACE	-	1	8					
9	1	-		SPACE							SPACE	-	1	10					
11	1	-		SPACE							SPACE	-	1	12					
13	1	-		SPACE							SPACE	-	1	14					
15	1	-		SPACE							SPACE	-	1	16					
17	1	-		SPACE							SPACE	-	1	18					
19	1	-		SPACE							SPACE	-	1	20					
TOTAL V-A						3,483	3,333	3,333				10,150	VA						
TOTAL AMPS						29	28	28				28	A						
A.I.C. RATING: 10,000																			

PANEL '1E-NT1'																			
MFR/MODEL: SQUARE 'D' TYPE NQ					VOLTS: 120/208V,3PH,4W					ENCLOSURE: NEMA 1					225 A				
NOTE	CIRC	POLE	AMPS	SERVICE	TYPE	VOLT-AMPS			MTG: SURFACE			AMPS	POLE	CIRC	NOTE				
						A	B	C	TYPE	SERVICE									
1	3	30	AM	RK-A119-1B	MISC	3,333						SPARE	20	1	2				
3	3	30	AM		MISC		3,333	720				RECP	20	1	4				
5	3	30	AM		MISC				3,333	720		RECP	20	1	6				
7	3	50	AM	12-IU-6	MOTR	4,512	180					RECP	20	1	8				
9	3	50	AM		MOTR		4,512					SPARE	20	1	10				
11	3	50	AM		MOTR							SPARE	20	1	12				
13	3	15	AM	12-CU-6	MOTR	360				4,512		SPARE	20	1	14				
15	3	15	AM		MOTR			360				SPARE	20	1	16				
17	3	15	AM		MOTR				360			SPARE	20	1	18				
19	1	-	SPACE									SPACE	-	1	20				
21	1	-	SPACE									SPACE	-	1	22				
23	1	-	SPACE									SPACE	-	1	24				
25	1	-	SPACE									SPACE	-	1	26				
27	1	-	SPACE									SPACE	-	1	28				
29	1	-	SPACE									SPACE	-	1	30				
TOTAL V-A						8,385	8,925		8,925				26,236	VA					
TOTAL AMPS						70	74		74				73	A					
A.I.C. RATING: 22,000																			
						LTG	RECP	MOTR	LG MT	MISC	KIT	HEAT	SPEC	TOTAL		AMPS			
CONNECTED LOAD IN KVA (THIS PANEL):						0.00	1.62	14.62	3.38	10.00	0.00	0.00	0.00	26.2 KVA		73	A		
CONNECTED LOAD IN KVA (BRANCH PANELS):														0.0 KVA		0	A		
TOTAL CONNECTED LOAD IN KVA:						0.00	1.62	14.62	3.38	10.00	0.00	0.00	0.00	26.2 KVA		73	A		
DEMAND LOAD IN KVA:						0.00	1.62	14.62	3.38	10.00	0.00	0.00	0.00	29.6 KVA		82	A		
PANEL NOTES:																			
a FED FROM PANEL '12-NDP2'																			
PANEL OPTIONS:																			
MAIN CIRCUIT BREAKER (SEE ONE-LINE FOR SIZE)																			

PANEL '1N-EQT1'																
MFR/MODEL: SQUARE 'D' TYPE NQ						VOLTS: 120/208V,3PH,4W			ENCLOSURE: NEMA 1			100 A				
NOTE	CIRC	POLE	AMPS	SERVICE	TYPE	VOLT-AMPS			MTG: SURFACE			AMPS	POLE	CIRC	NOTE	
						A	B	C	TYPE	SERVICE						
1	3	30		RK-C105-1A	MISC	3,333	138		LTG	TR C106D, RM C106C LTG	20	1	2			
3	3	30	AAA		MISC	3,333				SPARE	20	1	4			
5	3	30	AAA		MISC			3,333		SPARE	20	1	6			
7	3	60	AAA	PANEL 'S3-EQB-T1'	FEDR	3,383				SPACE	-	1	8			
9	3	60	AAA		FEDR		3,573			SPACE	-	1	10			
11	3	60	AAA		FEDR			3,333		SPACE	-	1	12			
13	1	-	SPACE							SPACE	-	1	14			
15	1	-	SPACE							SPACE	-	1	16			
17	1	-	SPACE							SPACE	-	1	18			
19	1	-	SPACE							SPACE	-	1	20			
TOTAL V-A						6,855	6,907	6,667				20,428	VA			
TOTAL AMPS						57	58	56				57	A			
A.I.C. RATING: 10,000																
						LTG	REC'D	MOTR	LG.MT	MISC	KIT	HEAT	SPEC	TOTAL	AMPS	
CONNECTED LOAD IN KVA (THIS PANEL):						0.14	0.00	0.00	0.00	10.00	0.00	0.00	0.00	10.1 KVA	28	A
CONNECTED LOAD IN KVA (BRANCH PANELS):						0.24	0.00	0.00	0.00	10.05	0.00	0.00	0.00	10.3 KVA	29	A
TOTAL CONNECTED LOAD IN KVA:						0.38	0.00	0.00	0.00	20.05	0.00	0.00	0.00	20.4 KVA	57	A
DEMAND LOAD IN KVA:						0.47	0.00	0.00	0.00	20.05	0.00	0.00	0.00	20.5 KVA	57	A
PANEL NOTES:										PANEL OPTIONS:						
a FED FROM PANEL '12-EQDP'.										MAIN CIRCUIT BREAKER (SEE ONE-LINE FOR SIZE)						

PANEL '3N-EQT'1																
MFR/MODEL: SQUARE 'D' TYPE NQ						VOLTS: 120/208V,3PH,4W				ENCLOSURE: NEMA 1				100 A		
NOTE	CIRC	POLE	AMPS	SERVICE	TYPE	VOLT-AMPS				MTG: SURFACE	SERVICE	AMPS	POLE	CIRC	NOTE	
						A	B	C	TYPE							
	1	3	30	RK-B302-1A	MISC	3,333	176			LTG	TELECOM RM B303 LTG	20	1	2		
	3	3	30	AAA	MISC		3,333				SPACE	20	1	4		
	5	3	30	AAA	MISC				3,333		SPACE	20	1	6		
	7	1	-	SPACE							SPACE	-	1	8		
	9	1	-	SPACE							SPACE	-	1	10		
	11	1	-	SPACE							SPACE	-	1	12		
	13	1	-	SPACE							SPACE	-	1	14		
	15	1	-	SPACE							SPACE	-	1	16		
	17	1	-	SPACE							SPACE	-	1	18		
	19	1	-	SPACE							SPACE	-	1	20		
TOTAL V-A						3,509	3,333		3,333			10,176	VA			
TOTAL AMPS						29	28		28			28	A			
A.I.C. RATING: 10,000																
						LTG	REC.P	MOT.R	LG.MT	MISC	KIT	HEAT	SPEC	TOTAL	AMPS	
CONNECTED LOAD IN KVA (THIS PANEL):						0.18	0.00	0.00	0.00	10.00	0.00	0.00	0.00	10.2 KVA	28	A
CONNECTED LOAD IN KVA (BRANCH PANELS):														0.0 KVA	0	A
TOTAL CONNECTED LOAD IN KVA:						0.18	0.00	0.00	0.00	10.00	0.00	0.00	0.00	10.2 KVA	28	A
DEMAND LOAD IN KVA:						0.22	0.00	0.00	0.00	10.00	0.00	0.00	0.00	10.2 KVA	28	A
PANEL NOTES: a FED FROM PANEL '12-EODP'.											PANEL OPTIONS: MAIN CIRCUIT BREAKER (SEE ONE-LINE FOR SIZE)					

PANEL '3N-NT1'

MFR/MODEL: SQUARE 'D' TYPE NQ

VOLTS: 120/208V/3PH/4W

ENCLOSURE: NEMA 1

225 A

NOTE	CIRC	POLE	AMPS	SERVICE	TYPE	VOLT-AMPS			MTG:	SURFACE	TYPE	SERVICE	AMPS	POLE	CIRC	NOTE
						A	B	C								
	3	3	30	RK-B302-1B	MISC	3,333	:				SPARE		20	1	2	
	3	3	30	AM	MISC		3,333	: 720			RECP	TR EAST RECP	20	1	4	
	5	3	30	AM	MISC			3,333	: 720		RECP	TR WEST RECP	20	1	6	
	7	3	60	12-IU-8	MOTR	5,136	: 720				RECP	RECP - OFFIC 304	20	1	8	
	9	3	60	AM	MOTR		5,136	:			SPARE		20	1	10	
	11	3	60	AM	MOTR			5,136	:		SPARE		20	1	12	
	13	3	45	12-CU-8	MOTR	2,808	:				SPARE		20	1	14	
	15	3	45	AM	MOTR		2,808	:			SPARE		20	1	16	
	17	3	45	AM	MOTR			2,808	:		SPARE		20	1	18	
	19	1	-	SPACE							SPACE		-	1	20	
	21	1	-	SPACE							SPACE		-	1	22	
	23	1	-	SPACE							SPACE		-	1	24	
	25	1	-	SPACE							SPACE		-	1	26	
	27	1	-	SPACE							SPACE		-	1	28	
	29	1	-	SPACE							SPACE		-	1	30	
TOTAL V-A						11,997		11,997		11,997			35,992	VA		
TOTAL AMPS						100		100		100			100	A		
A.I.C. RATING: 22,000																
						LTG	RECP	MOTR	LG MT	MISC	KIT	HEAT	SPEC	TOTAL		AMPS
CONNECTED LOAD IN KVA (THIS PANEL)						0.00	2.16	23.83	3.85	10.00	0.00	0.00	0.00	36.0 KVA	100	A
CONNECTED LOAD IN KVA (BRANCH PANELS)						0.00	2.16	23.83	3.85	10.00	0.00	0.00	0.00	0.0 KVA	0	A
TOTAL CONNECTED LOAD IN KVA						0.00	2.16	23.83	3.85	10.00	0.00	0.00	0.00	36.0 KVA	100	A
DEMAND LOAD IN KVA						0.00	2.16	23.83	3.85	10.00	0.00	0.00	0.00	39.8 KVA	111	A
PANEL NOTES: a FED FROM BUILDING 12 MAIN SWITCHGEAR - NORMAL POWER SECTION.												PANEL OPTIONS: MAIN CIRCUIT BREAKER (SEE ONE-LINE FOR SIZE)				

PANEL '4E-EQT'1						MFR/MODEL: SQUARE 'D' TYPE NQ						VOLTS: 120/208V,3PH,4W						ENCLOSURE: NEMA 1						100 A					
						VOLT-AMPS						MTG: SURFACE																	
NOTE	CIRC	POLE	AMPS	SERVICE	TYPE	A		B		C		TYPE	SERVICE	AMPS	POLE	CIRC	NOTE												
1	3	30	30	RK-404C-1A	MISC	3.333	:	100				LTG	TELECOM RM 404C LTG	20	1	2													
3	3	30	30	AM	MISC			3.333	:				SPACE	20	1	4													
5	3	30	30	AM	MISC					3.333	:		SPACE	20	1	6													
7	1	-	-	SPACE									SPACE	-	1	8													
9	1	-	-	SPACE									SPACE	-	1	10													
11	1	-	-	SPACE									SPACE	-	1	12													
13	1	-	-	SPACE									SPACE	-	1	14													
15	1	-	-	SPACE									SPACE	-	1	16													
17	1	-	-	SPACE									SPACE	-	1	18													
19	1	-	-	SPACE									SPACE	-	1	20													
TOTAL V-A						3.433		3.333		3.333				10,100	VA														
TOTAL AMPS						29		28		28				28	A														
A.I.C. RATING: 10,000																													
						LTG	RECP	MOTR	LG.MT	MISC	KIT	HEAT	SPEC	TOTAL		AMPS													
CONNECTED LOAD IN KVA (THIS PANEL):						0.10	0.00	0.00	0.00	0.00	0.00	0.00	0.00		10.1 KVA	28	A												
CONNECTED LOAD IN KVA (BRANCH PANELS):															0.0 KVA	0	A												
TOTAL CONNECTED LOAD IN KVA:						0.10	0.00	0.00	0.00	10.00	0.00	0.00	0.00		10.1 KVA	28	A												
DEMAND LOAD IN KVA:						0.13	0.00	0.00	0.00	10.00	0.00	0.00	0.00		10.1 KVA	28	A												
PANEL NOTES: ■ FED FROM PANEL '12-EODP'.																													
PANEL OPTIONS: MAIN CIRCUIT BREAKER (SEE ONE-LINE FOR SIZE)																													

PANEL '4N-NT1'

MFR/MODEL: SQUARE 'D' TYPE NQ

VOLTS: 120/208V,3PH,4W

ENCLOSURE: NEMA 1

225 A

NOTE	CIRC	POLE	AMPS	SERVICE	TYPE	VOLT-AMPS			MTG:	SURFACE	TYPE	SERVICE	AMPS	POLE	CIRC	NOTE
						A	B	C								
	3	3	30	RK-404C-1B	MISC	3,333						SPARE	20	1	2	
	3	3	30	AAA	MISC		3,333	720			RECP	TR EAST RECP	20	1	4	
	5	3	30	AAA	MISC			3,333	720		RECP	TR WEST RECP	20	1	6	
	7	3	90	12-IU-9	MOTR	8,100	180				RECP	EXTERIOR RECP 12-CU-9	20	1	8	
	9	3	90	AAA	MOTR		8,100					SPARE	20	1	10	
	11	3	90	AAA	MOTR			8,100				SPARE	20	1	12	
	13	3	15	12-CU-9	MOTR	360						SPARE	20	1	14	
	15	3	15	AAA	MOTR		360					SPARE	20	1	16	
	17	3	15	AAA	MOTR			360				SPARE	20	1	18	
	19	1	-	SPACE								SPACE	-	1	20	
	21	1	-	SPACE								SPACE	-	1	22	
	23	1	-	SPACE								SPACE	-	1	24	
	25	1	-	SPACE								SPACE	-	1	26	
	27	1	-	SPACE								SPACE	-	1	28	
	29	1	-	SPACE								SPACE	-	1	30	
TOTAL V-A						11,973	12,513	12,513	37,000				VA			
TOTAL AMPS						100	104	104	103				A			
A.I.C. RATING: 22,000																
						LTG	RECP	MOTR	LG.MT	MISC	KIT	HEAT	SPEC	TOTAL	AMPS	
CONNECTED LOAD IN KVA (THIS PANEL)						0.00	1.62	25.38	6.08	10.00	0.00	0.00	0.00	37.0 KVA	103	A
CONNECTED LOAD IN KVA (BRANCH PANELS)														0.0 KVA	0	A
TOTAL CONNECTED LOAD IN KVA						0.00	1.62	25.38	6.08	10.00	0.00	0.00	0.00	37.0 KVA	103	A
DEMAND LOAD IN KVA						0.00	1.62	25.38	6.08	10.00	0.00	0.00	0.00	43.1 KVA	120	A

PANEL NOTES:

a FED FROM BUILDING 12 MAIN SWITCHGEAR - NORMAL POWER SECTION

PANEL OPTIONS:

MAIN CIRCUIT BREAKER (SEE ONE-LINE FOR SIZE)

[illegible][illegible]

CONSULTANT

A/E:
GDM
1000 W STEUBEN STR, UNIT 3
BINGEN, WA 98605
541.436.4723
ADAM GOODIN, PE

GDM
ARCHITECTS • ENGINEERS

ARCHITECT/ENGINEER OF RECORD

R S A

Engineering, Inc.

MECHANICAL AND ELECTRICAL CONSULTING ENGINEERS
670 West Fireweed Lane, Suite 200
Anchorage, AK 99503
Phone (907) 276-0521
Corporate No.: AEC0542

STAMP

STATE OF ALASKA
40th
JAM
JEREMY A. MAXIE
EE-113847
3/19/22
REGISTERED PROFESSIONAL ENGINEER

**PROGRAM
CONTRACTING
ACTIVITY
CENTRAL (PCAC)**

VA | U.S. Department
of Veterans Affairs

DRAWING TITLE
BUILDING 12 - PANEL SCHEDULES
APPROVED: Project Director

PHASE	100% CD FINAL SOLUTION
FLS	FULLY SPRINKLERED

PROJECT TITLE		
EHRM INFRASTRUCTURE UPGRADES		
LOCATION		
HOT SPRINGS, SOUTH DAKOTA		
ISSUE DATE	CHECKED BY	DRAWN BY
02/22/2022	JAM	CSZ

PROJECT NUMBER
568A4-21-702
BUILDING NUMBER
N/A
DRAWING NUMBER
EK-113

EXISTING PANEL '14-N1-1'															
MFR/MODEL: SQUARE D TYPE NQ						VOLTS: 120/208V,3PH,4W				ENCLOSURE: NEMA 1				200 A	
NOTE	CIRC	POLE	AMPS	SERVICE	TYPE	VOLT-AMPS			MTG. SURFACE			AMPS	POLE	CIRC	NOTE
a	1	1	20	DED CIRC. ASSISTANT OFFICE	MISC	A	B	C	TYPE	SERVICE	20	1	2	a	
a	3	1	20	LTG CHIEF & ASSISTANT						LTG MAIN ROOM	20	1	4	a	
a	5	1	20	RECP CHIEF & ASSISTANT						RESTROOM	20	1	6	a	
a	7	1	20	RECP SHORT WALL						RECP SOUTH & EAST WALL	20	1	8	a	
a	9	1	20	RECP CONTRACT OFFICE						RECP SOUTH & WEST	20	1	10	a	
a	11	1	20	GAS PUMP						LTG CRAWL SPACE	20	1	12	a	
a	13	1	20	GREASE HOUSE						MAIN FLOOR RECP	20	1	14	a	
a	15	1	20	FLOOR RECP ASSISTANT OFFICE						FA-14 FIRE ALARM PANEL	20	1	16	a	
d	17	1	20	EXTERIOR RECP 14-CU-1, 14-DDC-1			590			SPARE	20	3	18	a	
a	19	2	60	A/C						A/C OUTSIDE UNIT	50	3	20	a	
a	21	2	60	AA						AAA	50	3	22	a	
a	23	1	20	LTG MAIN OFFICE						RECP EXTERIOR	20	1	24	a	
a	25	1	20	RECP EXTERIOR						RECP CHIEF & ASSISTANT	20	1	26	a	
a	27	1	20	PAINT STORAGE BLDG						SPARE	20	1	28	a	
a	29	1	20	UNKNOWN						OFFICE RECP	20	1	30	a	
a.c	31	1	20	A/C AIR HANDLER		MISC	1,920			PANEL 14-N2-1	100	3	32	a	
a.c	33	2	30	HOT WATER HEATER					AAA	100	3	34	a		
a.c	35	2	30	AA					AAA	100	3	36	a		
d	37	1	20	RK-105-1A						METER (LIGHTS)	20	3	38	a	
a	39	-		SPACE						AAA	20	3	40	a	
a	41	-		SPACE					AAA	20	3	42	a		
TOTAL V-A						1,920	0	590					2,510	VA	
TOTAL AMPS						16	0	5					7	A	
A.I.C. RATING: 22,000															
						LTG	RECP	MOTR	LG.MT	MISC	KIT	HEAT	SPEC	TOTAL	AMPS
CONNECTED LOAD IN KVA (THIS PANEL):						0.00	0.00	0.00	0.00	2.51	0.00	0.00	0.00	2.5 KVA	7 A
CONNECTED LOAD IN KVA (BRANCH PANELS):														0.0 KVA	A
TOTAL CONNECTED LOAD IN KVA:						0.00	0.00	0.00	0.00	2.51	0.00	0.00	0.00	2.5 KVA	7 A
DEMAND LOAD IN KVA:						0.00	0.00	0.00	0.00	2.51	0.00	0.00	0.00	2.5 KVA	7 A
PANEL NOTES:															
a EXISTING LOAD															
b BUS HOLE STRIPPED															
c EXISTING LOAD SHIFTED UP															
d INSTALL NEW CIRCUIT BREAKER IN SPACE AVAILABLE IN THE PANEL. THE NEW CIRCUIT BREAKER SHALL BE COMPATIBLE WITH AND LISTED FOR USE IN THE PANEL.															
PANEL OPTIONS:															
MAIN CIRCUIT BREAKER (SEE ONE-LINE FOR SIZE)															

EXISTING PANEL '17-N1-2'															
MFR/MODEL: EATON PRL1a PANEL BOARD						VOLTS: 120/208V,3PH,4W			ENCLOSURE: NEMA 1			225 A			
VOLT-AMPS						MTG: SURFACE									
NOTE	CIRC	POLE	AMPS	SERVICE	TYPE	A	B	C	TYPE	SERVICE	AMPS	POLE	CIRC	NOTE	
	1	3	90	SPARE					AAA	AIR COMPRESSOR	20	3	2	a	
	3	3	90	AAA					AAA		20	3	4	a	
	5	3	90	AAA					AAA		20	3	6	a	
a	7	1	20	BENCH GRINDER					AAA	SHOP MACHINERY	20	3	8	a	
a	9	1	15	SPRINKLER					AAA		20	3	10	a	
a	11	1	15	RECP RECP					AAA		20	3	12	a	
a	13	3	100	GREENHOUSE						SHOP MACHINERY	20	2	14	a	
a	15	3	100	AAA					AA		20	2	16	a	
a	17	3	100	AAA						RECO NORTH LARGE BAY	15	1	18	a	
a	19	1	20	GREENHOUSE						RECP LARGE BAY	20	1	20	a	
a	21	1	20	LTG UPSTAIRS						SPARE	20	1	22		
a	23	3	20	LTG STREET						SMOKE ELIMINATOR	25	3	24	a	
a	25	3	20	AAA					AAA		25	3	26	a	
a	27	3	20	AAA					AAA		25	3	28	a	
a	29	1	20	FIRE ALARM						GARAGE DOOR	20	1	30	c,d	
	31	2	15	SPARE						GARAGE DOOR	20	1	32	c,d	
	33	2	15	AA						GARAGE DOOR	20	1	34	c,d	
a	35	1	15	RECP NORTH						SPARE BAY RECP FOR WINCH CENTER	20	1	36	b	
d	37	1	20	RK-101-1B	MISC RECP	1,920				SPACE	-	1	38		
d	39	1	20	TELECOM CAB RECP			360			SPACE	-	1	40		
	41	1	-	SPACE						SPACE	-	1	42		
	43	1	-	SPACE						SPACE	-	1	44		
	45	1	-	SPACE						SPACE	-	1	46		
	47	1	-	SPACE						SPACE	-	1	48		
	49	1	-	SPACE						SPACE	-	1	50		
	51	1	-	SPACE						SPACE	-	1	52		
	53	1	-	SPACE						SPACE	-	1	54		
	55	1	-	SPACE						SPACE	-	1	56		
	57	1	-	SPACE						SPACE	-	1	58		
	59	1	-	SPACE						SPACE	-	1	60		
	61	1	-	SPACE						SPACE	-	1	62		
	63	1	-	SPACE						SPACE	-	1	64		
	65	1	-	SPACE						SPACE	-	1	66		
	67	1	-	SPACE						SPACE	-	1	68		
	69	1	-	SPACE						SPACE	-	1	70		
	71	1	-	SPACE						SPACE	-	1	72		
TOTAL V-A						1,920	360	0	2,280 VA						
TOTAL AMPS						16	3	0	6 A						
A.I.C. RATING: 22,000															
						LTG	RECP	MOTR	LG.MT	MISC	KIT	HEAT	SPEC	TOTAL	AMPS
CONNECTED LOAD IN KVA (THIS PANEL):						0.00	0.36	0.00	0.00	1.92	0.00	0.00	0.00	2.3 KVA	6 A
CONNECTED LOAD IN KVA (BRANCH PANELS):														0 A	A
TOTAL CONNECTED LOAD IN KVA:						0.00	0.36	0.00	0.00	1.92	0.00	0.00	0.00	2.3 KVA	6 A
DEMAND LOAD IN KVA:						0.00	0.36	0.00	0.00	1.92	0.00	0.00	0.00	2.3 KVA	6 A
PANEL NOTES:															
a EXISTING LOAD															
b FIELD VERIFY IF CIRCUIT IS UNDER LOAD OR SPARE															
c EXISTING LOAD MOVED FROM PANEL 17-N1-1															
d INSTALL NEW CIRCUIT BREAKER IN SPACE AVAILABLE IN THE PANEL. THE NEW CIRCUIT BREAKER SHALL BE COMPATIBLE WITH AND LISTED FOR USE IN THE PANEL.															
PANEL OPTIONS: MAIN CIRCUIT BREAKER (SEE ONE-LINE FOR SIZE)															

EXISTING PANEL '14-N2-1'																
MFR/MODEL: SQUARE D TYPE NQ					VOLTS: 120/208V,3PH,4W			ENCLOSURE: NEMA 1			100 A					
NOTE	CIRC	POLE	AMPS	SERVICE	TYPE	VOLT-AMPS			MTG: SURFACE			AMPS	POLE	CIRC	NOTE	
						A	B	C		SERVICE						
a	1	1	20	ATTIC EXHAUST FAN & LIGHTS						LTG WEST OFFICE	20	1	2	a		
a	3	1	20	FAN RECP BEHIND A/C UNIT						LTG. RECP - BATHROOM & STAIR LTG	20	1	4	a		
a	5	1	20	RECP WEST OFFICE WEST WALL						SPARE	15	1	6	a		
a	7	1	20	RECP WEST OFFICE EAST WALL						LTG UTILITY CLOSET & NW OFFICE	20	1	8	a		
a	9	1	20	FAN RECP WEST OFFICES						RECP NORTH MIDDLE OFFICE	20	1	10	a		
a	11	1	20	RECP WEST MIDDLE & WEST WALL						LTG NORTH & NE MIDDLE OFFICE	20	1	12	a		
a	13	1	20	RECP NW & WEST OFFICES						LTG EAST OFFICE & HALL	20	1	14	a		
b	15	3	20	RK-105-1B	MISC		1,667			RECP EAST OFFICE WEST WALL	20	1	16	a		
b	17	3	20	AAA	MISC			1,667		LTG WEST MIDDLE OFFICE	20	1	18	a		
b	19	3	20	AAA	MISC	1,667				SPARE	20	1	20	a		
b	21	1	20	TELECOM RM LTG	LTG		50			FAN RECP EAST OFFICE	20	1	22	a		
b	23	2	45	14-IU-1	MOTR			3,557		RECP WATER COOLER & STAIRWAY	20	1	24	a		
b	25	2	45	AA	MOTR	3,557				SPARE	20	1	26	a		
b	27	2	40	14-CU-1	MOTR		2,132			A/C UNIT	20	2	28	a		
b	29	2	40	AA	MOTR			2,132		SPARE	20	2	30	a		
	31	1	20	SPARE						MAIN BREAKER	100	3	32	a		
	33	1	20	SPARE						AAA	100	3	34	a		
	35	1	20	SPARE						AAA	100	3	36	a		
TOTAL V-A						5,224	3,849	7,356	16,428						VA	
TOTAL AMPS						44	32	61	46						A	
A.I.C. RATING: 22,000																
						LTG	RECP	MOTR	LG MT	MISC	KIT	HEAT	SPEC	TOTAL	AMPS	
CONNECTED LOAD IN KVA (THIS PANEL):						0.05	0.00	11.38	1.78	5.00	0.00	0.00	0.00	16.4 KVA	46	A
CONNECTED LOAD IN KVA (BRANCH PANELS):													0.0 KVA	0	A	
TOTAL CONNECTED LOAD IN KVA:						0.05	0.00	11.38	1.78	5.00	0.00	0.00	16.4 KVA	46	A	
DEMAND LOAD IN KVA:						0.06	0.00	11.38	1.78	5.00	0.00	0.00	18.2 KVA	51	A	
PANEL NOTES:											PANEL OPTIONS:					
a EXISTING LOAD											MAIN CIRCUIT BREAKER (SEE ONE-LINE FOR SIZE)					
b INSTALL NEW CIRCUIT BREAKER IN SPACE AVAILABLE IN THE PANEL. THE NEW CIRCUIT BREAKER SHALL BE COMPATIBLE WITH AND LISTED FOR USE IN THE PANEL.																

EXISTING PANEL '23-NB-1'													
MFR/MODEL: SQUARE D TYPE NQDD						VOLTS: 120/240V 1PH 3W		ENCLOSURE: NEMA 1				100 A	
TYPE: PANELBOARD						VOLT-AMPS		MTG: RECESSED					
NOTE	CIRC	POLE	AMP'S	SERVICE	TYPE	A	B	TYPE	SERVICE	AMPS	POLE	CIRC	NOTE
b	1	2	20		MISC	1,920			UNKNOWN	1	2	a	
a	3	1		UNKNOWN					UNKNOWN	1	4	a	
a	5	1		UNKNOWN					UNKNOWN	1	6	a	
a	7	1		UNKNOWN					UNKNOWN	1	8	a	
a	9	1		UNKNOWN					UNKNOWN	1	10	a	
a	11	1		UNKNOWN					UNKNOWN	1	12	a	
a	13	1		UNKNOWN					UNKNOWN	1	14	a	
a	15	1		UNKNOWN					UNKNOWN	1	16	a	
a	17	1		UNKNOWN					UNKNOWN	1	18	a	
a	19	1		UNKNOWN					UNKNOWN	1	20	a	
a	21	1		UNKNOWN					UNKNOWN	1	22	a	
a	23	1		UNKNOWN					UNKNOWN	1	24	a	
a	25	1		UNKNOWN					UNKNOWN	1	26	a	
a	27	1		UNKNOWN					UNKNOWN	1	28	a	
a	29	1		UNKNOWN					UNKNOWN	1	30	a	
a	31	1		UNKNOWN					UNKNOWN	1	32	a	
a	33	1		UNKNOWN					UNKNOWN	1	34	a	
a	35	1		UNKNOWN					UNKNOWN	1	36	a	
a	37	1		UNKNOWN					UNKNOWN	1	38	a	
a	39	1		UNKNOWN					UNKNOWN	1	40	a	
a	41	1							UNKNOWN	1	42	a	
TOTAL V-A						1,920	0	1,920 VA					
TOTAL AMPS						16	0	8 A					
A.I.C. RATING: 22,000													
CONNECTED LOAD IN KVA (THIS PANEL) CONNECTED LOAD IN KVA (BRANCH PANELS) TOTAL CONNECTED LOAD IN KVA: DEMAND LOAD IN KVA:						LTG	RECP	MOTR	LG.MT	MISC	SPEC	TOTAL	AMPS
						0.00	0.00	0.00	0.00	1.92	0.00	1.9 KVA	8 A
						0.00	0.00	0.00	0.00	1.92	0.00	0.0 KVA	0 A
						0.00	0.00	0.00	0.00	1.92	0.00	1.9 KVA	8 A
PANEL NOTES:													
a (E) PANEL LOADS UNKNOWN													
b INSTALL NEW CIRCUIT BREAKER IN SPACE AVAILABLE IN THE PANEL. THE NEW CIRCUIT BREAKER SHALL BE COMPATIBLE WITH AND LISTED FOR USE IN THE PANEL.													
PANEL OPTIONS: MAIN LUGS ONLY													

PROJECT NUMBER
568A4-21-702
BUILDING NUMBER
N/A
DRAWING NUMBER
EK-115

A

B

C

A

B

C

EXISTING PANEL '#1'													
MFR/MODEL: SQUARE 'D' TYPE NOOD					VOLTS: 120/240V, 1PH, 3W			ENCLOSURE: NEMA 1			xxx A		
TYPE: PANELBOARD					VOLT-AMPS			MTG: RECESSED					
NOTE	CIRC	POLE	AMPS	SERVICE	TYPE	A	B	TYPE	SERVICE	AMPS	POLE	CIRC	NOTE
a	1	1	15	LTG					UPSTAIRS N. A/C	20	1	2	a
a	3	1	15	LTG					BEDROOM A/C	20	1	4	a,c
a	5	1	15	RECP LIVING RM, LTG PORCH					MAIN FLOOR WASHER	20	1	6	a
a	7	1	20	UPSTAIRS BR GFCI					BASEMENT & MAIN FLOOR LTG	15	1	8	a
a	9	1	20	HANDICAP GFCI IN BR					BASEMENT RECP/WATER PMP	15	1	10	a,c
a,b	11	1	15	RECEP HANDICAP BEDROOM					BR & HANDICAP BEDROOM LTG	15	1	12	a
a,b	13	1	15	UPSTAIRS SOUTH BEDROOM RECP					GFCI BY PANEL	20	1	14	a
a,b	15	1	15	UPSTAIRS NORTH BEDROOM RECP					GFCI IN WASHROOM	15	1	16	a
a	17	1	20	HANDICAP BEDROOM					XXX	20	2	18	a,c
a	19	1	20	A/C RECP					MA	20	2	20	a,c
a	21	2	30	HOTWATER HEATER					MAIN FLOOR DRYER	30	2	22	a
a	23	2	30	MA					MA	30	2	24	a
a	25	2	20	FREEZER BASE					NEW WATERHEATER	30	2	26	a
a	27	2	20	MA					MA	30	2	28	a
a	29	1	20	XXX					REFR. N.S.	20	1	30	a
a,c	31	2	20	RK-002-1A	MISC		1,920		SANKILL UNIT	15	1	32	a
d	33	1	-	SPACE		360		RECP	TELECOM CABINET RECP	20	1	34	d
	35	1	-	SPACE					SPACE	-	1	36	
	37	1	-	SPACE					SPACE	-	1	38	
	39	1	-	SPACE					SPACE	-	1	40	
	41	1	-	SPACE					SPACE	-	1	42	
TOTAL V-A						360	1,920						
TOTAL AMPS						3	16						
A.I.C. RATING: 22,000													
					LTG	RECP	MOTR	LG.MT	MISC	SPEC	TOTAL	AMPS	
CONNECTED LOAD IN KVA (THIS PANEL):					0.00	0.36	0.00	0.00	1.92	0.00	2.3 KVA	10 A	
CONNECTED LOAD IN KVA (BRANCH PANELS):					0.00	0.36	0.00	0.00	1.92	0.00	0.0 KVA	0 A	
TOTAL CONNECTED LOAD IN KVA:					0.00	0.36	0.00	0.00	1.92	0.00	2.3 KVA	10 A	
DEMAND LOAD IN KVA:					0.00	0.36	0.00	0.00	1.92	0.00	2.3 KVA	10 A	
PANEL NOTES:								PANEL OPTIONS:					
a EXISTING LOAD								MAIN LUGS ONLY					
b EXISTING GFCI BREAKER													
c UNIDENTIFIABLE CIRCUIT LABEL													
d INSTALL NEW CIRCUIT BREAKER IN SPACE AVAILABLE IN THE PANEL. THE NEW CIRCUIT BREAKER SHALL BE COMPATIBLE WITH AND LISTED FOR USE IN THE PANEL.													

EXISTING PANEL '#2'															
MFR/MODEL: SQUARE 'D' TYPE NOOD						VOLTS: 120/240V, 1PH, 3W			ENCLOSURE: NEMA 1			xxx A			
TYPE: PANELBOARD						VOLT-AMPS			MTG: RECESSED						
NOTE	CIRC	POLE	AMPS	SERVICE	TYPE	A	B	TYPE	SERVICE	AMPS	POLE	CIRC	NOTE		
a	1	2	50	RANGE					DINING ROOM A/C RECP	20	2	2	a		
a	3	2	50	AA					AA	20	2	4	a		
a	5	1	15	LTG BASEMENT					RECP EAST EXTERIOR	20	1	6	a		
a	7	1	20	HOTWATER PUMPS					DRYER BASEMENT	30	2	8	a		
a	9	1	20	PUMPS FOR WATER HEATER					AA	30	2	10	a		
a	11	1	20	WASHER					STEP & VATH ATTIC LTG	20	1	12	a		
a	13	1	15	GFCI BY PUMPS					BEDROOM & WHOLE HOUSE FAN	20	1	14	a		
a	15	1	15	BASEMENT GFCI ON POLE					GFCI NEXT TO PANEL	20	1	16	a		
a	17	1	15	RECP LIVING RM/PORCH LTG					DISHWASHER	20	1	18	a		
a	19	1	20	DINING ROOM AND FRIDGE RECP					UPSTAIRS BATH GFCI	20	1	20	a		
a,b	21	1	15	RECP S. UPSTAIR BDRM RECP					KITCHEN GFCI	20	1	22	a		
a,b	23	1	15	RECP N. UPSTAIR BDRM RECP					LIVING ROOM A/C RECP	20	1	24	a		
a	25	2	30	WATER HEATER					LIVING ROOM A/C RECP	20	1	26	a		
a	27	2	30	AA					HOOD	15	1	28	a		
a	29	1	20	KITCHEN GFCI					SINK LTG & BACKLIGHT	20	1	30	a		
a	31	1	20	MAIN FLOOR BATHROOM					POWER FOR FA	20	1	32	a		
a	33	1	15	FIRE ALARM PANEL					XXX	20	1	34	a,c		
d	35	2	30	RK-002-1B	MISC		1,920		SPACE	-	1	36			
	37	1	-	SPACE					SPACE	-	1	38			
	39	1	-	SPACE					SPACE	-	1	40			
	41	1	-	SPACE					SPACE	-	1	42			
TOTAL V-A							0	1,920		1,920	VA				
TOTAL AMPS							0	16		8	A				
A.I.C. RATINGS: 22,000															
						LTG	RECP	MOTR	LG.MT	MISC	SPEC	TOTAL	AMPS		
CONNECTED LOAD IN KVA (THIS PANEL):						0.00	0.00	0.00	0.00	1.92	0.00	1.9 KVA	8 A		
CONNECTED LOAD IN KVA (BRANCH PANELS):												0.0 KVA	0 A		
TOTAL CONNECTED LOAD IN KVA:						0.00	0.00	0.00	0.00	1.92	0.00	1.9 KVA	8 A		
DEMAND LOAD IN KVA:						0.00	0.00	0.00	0.00	1.92	0.00	1.9 KVA	8 A		
PANEL NOTES:									PANEL OPTIONS:						
a EXISTING LOAD									MAIN LUGS ONLY						
b EXISTING GFCI BREAKER															
c UNIDENTIFIABLE CIRCUIT LABEL															
d INSTALL NEW CIRCUIT BREAKER IN SPACE AVAILABLE IN THE PANEL. THE NEW CIRCUIT BREAKER SHALL BE COMPATIBLE WITH AND LISTED FOR USE IN THE PANEL.															

EXISTING PANEL '43-N1-2'																
MFR/MODEL: CUTLER HAMMER TYP PRL1						VOLTS: 120/208V,3PH,4W				ENCLOSURE: NEMA 1				225 A		
NOTE	CIRC	POLE	AMPS	SERVICE	TYPE	A	B	C	TYPE	MTG: SURFACE	SERVICE	AMPS	POLE	CIRC	NOTE	
a	1	1	20	STREET LTG CONTROLS							SHREDDER VACUUM	20	3	2	a	
a	3	2	20	BAND SAW RECP							SPARE W/ #2	20	3	4	a	
a	5	2	20	AA							RECP ELECTRIC STORAGE AND LAUNDRY	20	3	6	a	
a	7	3	30	OVERHEAD FANS							RECP ELECTRIC STORAGE AND LAUNDRY	20	1	8	a	
a	9	3	30	AAA							RECP ELECTRIC STORAGE AND LAUNDRY	20	1	10	a	
a	11	3	30	AAA							RECP LAUNDRY	20	1	12	a	
	13	3	30	SPARE							AIR HANDLER	20	3	14	a	
	15	3	30	AAA							AA	20	3	16	a	
	17	3	30	AAA							AA	20	3	18	a	
a	19	1	20	HOT WATER HEATER IN CRAWL SPACE							AIR CURTAIN	60	2	20	a	
a	21	1	20	DOOR SECURITY P2000 CONTROLLER JOHNSON CONTROLS							AA	60	2	22	a	
	23	1	20	SPARE							SPARE	20	1	24		
	25	3	20	SPARE							SPARE	20	3	26		
	27	3	20	AAA							SPARE	20	3	28		
	29	3	20	AAA							SPARE	20	3	30		
	31	1	20	SPARE		1,920					MISC RK-B01-1A	20	3	32	c	
	33	1	20	SPARE							SPARE	20	1	34		
	35	1	20	SPARE							SPARE	20	1	36		
a	37	1	20	WORKBENCH RECP							SPARE	50	3	38		
a	39	2	30	STREET LTG							SPARE	50	3	40		
a	41	2	30	AA							SPARE	50	3	42		
TOTAL V-A						1,920		0		0		1,920	VA			
TOTAL AMPS						16		0		0		5	A			
A.I.C. RATING: 22,000																
						LTG	RECP	MOTR	LG.MT	MISC	KIT	HEAT	SPEC	TOTAL	AMPS	
CONNECTED LOAD IN KVA (THIS PANEL):						0.00	0.00	0.00	0.00	1.92	0.00	0.00		1.9 KVA	5	A
CONNECTED LOAD IN KVA (BRANCH PANELS):														0.0 KVA	0	A
TOTAL CONNECTED LOAD IN KVA:						0.00	0.00	0.00	0.00	1.92	0.00	0.00	0.00	1.9 KVA	5	A
DEMAND LOAD IN KVA:						0.00	0.00	0.00	0.00	1.92	0.00	0.00	0.00	1.9 KVA	5	A
PANEL NOTES:										PANEL OPTIONS:						
a EXISTING LOAD										MAIN LUGS ONLY						
b INSTALL NEW CIRCUIT BREAKER IN SPACE AVAILABLE IN THE PANEL THE NEW CIRCUIT BREAKER																
SHALL BE COMPATIBLE WITH AND LISTED FOR USE IN THE PANEL.																
c NEW LOAD ON EXISTING BREAKER																

B

B

C

E**F****F**

ELECTRICAL SERVICE LOAD CALCULATION - DOM EM BRANCH				
SEE ONE-LINE FOR EQUIPMENT AND FEEDER SIZES				
ASSUMED FULL MEASURED LOAD ON SERVICE 'A' IS ON PANEL '2-NDB-1'	139,783	VA		
NEW DEMAND LOAD ADDED FROM NEW PANEL 2-NB-1	18,684	VA		
TOTAL CALCULATED DEMAND LOAD ON PANEL '2-NDB-1'	158,467	VA	=	440 A
ASSUMED 50% MEASURED LOAD ON SERVICE 'A' IS ON PANEL '2-EQDB-1'	69,892	VA		
NEW LOAD ADDED	83,393	VA	=	231 A
TOTAL CALCULATED DEMAND LOAD ON '2-EQDB-1'	153,285	VA	=	425 A
SEE INDIVIDUAL PANELS FOR LOAD CALCULATIONS.				
EXISTING SERVICE AND DISTRIBUTION EQUIPMENT HAVE ADEQUATE CAPACITY FOR NEW LOAD ADDED.				

ELECTRICAL SERVICE LOAD CALCULATION -DOM SECTION B				
SEE ONE-LINE FOR EQUIPMENT AND FEEDER SIZES				
PEAK DEMAND LOAD MEASURED ON SERVICE SECTION 'A'	287,277	VA		
SOUTH BUS DUCT SECTION EXISTING LOAD IS ASSUMED 35% OF SECTION 'B' LOAD:	126	KVA		
NEW DEMAND LOAD ADDED FROM NEW PANELS:	43	KVA		
NEW LOAD ADDED ON BLDG 4 PANELS	NO.	VA		
RK-04,103,203	3	5,000	15,000	VA
4-CU-1,2,3	3	3,848	11,544	VA
4-IU-1	1	7,114	7,114	VA
4-IU-2,3	2	6,240	12,480	VA
EXT RECP	2	180	360	VA
DDC	3	50	150	VA
TOTAL LOAD ADDED		46,648	VA	
NEW CALCULATED LOAD ON SOUTH BUS DUCT	216	KVA	=	599 A
NORTH BUS DUCT SECTION EXISTING LOAD IS ASSUMED 35% OF SECTION 'B' LOAD:	126	KVA		
NEW DEMAND LOAD ADDED FROM NEW PANELS:	156	KVA		
NEW CALCULATED LOAD ON NORTH BUS DUCT	281	KVA	=	781 A
TOTAL LOAD ADDED TO SECTION 'A' SERVICE FROM ABOVE:	246	KVA		
NEW UNIT HEATER LOAD ON SERVICE	38	KVA		
NEW CALCULATED DEMAND LOAD ON SERVICE SECTION 'A':	571	KVA	=	1,584 A
EXISTING SERVICE AND DISTRIBUTION EQUIPMENT HAVE ADEQUATE CAPACITY FOR NEW LOAD ADDED.				

EQUIPMENT BRANCH LOAD CALCULATION			
EXISTING DISTRIBUTION PANEL '12-EQDP' IS FED FROM THE NORMAL POWER SWITCHBOARD VIA A 800A, 120/208V, ATS AND 800A, 3P BREAKER WITH (2) 3.5"C, 4#500KCMIL AND #1/0 GND.			
SEE PANEL SCHEDULES FOR LOAD CALCULATION FOR INDIVIDUAL PANELS.			
NORTH TELECOM ROOMS EQUIPMENT BRANCH FEEDER CALCULATED NEC DEMAND LOAD FROM PANEL SCHEDULES	61,468	VA	= 171 A
UPS DEMAND LOAD	70,210	VA	= 195
EAST TELECOM ROOMS EQUIPMENT BRANCH FEEDER CALCULATED NEC DEMAND LOAD FROM PANEL SCHEDULES	15,313	VA	= 43 A
NEW LOAD ADDED TO PANEL '12-EQDP'	76,780	VA	= 213 A
EXISTING DEMAND LOAD ON PANEL '12-EQDP'	115,200	VA	
NEW CALCULATED DEMAND LOAD ON PANEL	262,190	VA	= 728 A
EXISTING SERVICE AND DISTRIBUTION EQUIPMENT HAVE ADEQUATE CAPACITY FOR NEW LOAD ADDED.			

LIFE SAFETY LOAD CALCULATION				
EXISTING DISTRIBUTION PANEL '12-LSDP' IS FED FROM THE NORMAL POWER SWITCHBOARD VIA A 400A, 120/208V, ATS AND 400A, 3P BREAKER WITH 3.5"C, 4#500KCMIL AND #4/0 GND.				
EXISTING PANEL 'BE-LS1' FED FROM '12-LSDP' WITH 150A, 3P BREAKER AND 1.5"C, 4#1 AND 1#8 GND.				
EXISTING DEMAND ON '12-LSDP'	95,040	VA		
125% OF EXISTING PER NEC 220.87	118,800	VA		
NEW LOAD ADDED	NO.	VA		
TELECOMM RACKS	2	5,000	10,000	VA
TOTAL LOAD ADDED		10,000	VA	
NEW CALCULATED LOAD ON 12-LSDP	128,800	VA	=	358 A
SEE PANEL SCHEDULE FOR LOAD CALC ON PANEL 'BE-LS1'				
EXISTING DISTRIBUTION EQUIPMENT HAS ADEQUATE CAPACITY FOR NEW LOAD ADDED.				

ELECTRICAL SERVICE LOAD CALCULATION				
EXISTING DISTRIBUTION PANEL '12-NDP2' IS FED FROM THE NORMAL POWER SWITCHBOARD VIA AN 800A, 3P BREAKER WITH (2) 3.5"C, 4#500KCMIL AND #1/0 GND.				
SEE PANEL SCHEDULES FOR LOAD CALCULATION ON INDIVIDUAL PANELS.				
EAST TELECOM ROOMS NORMAL POWER BRANCH FEEDER CALCULATED NEC DEMAND LOAD FROM PANEL SCHEDULES	50,856	VA	=	141 A
DEMAND LOAD ON PANEL 'BE-NT1'	10,000	VA		
NEW DEMAND LOAD ADDED TO PANEL '12-NDP2'	60,856	VA	=	169 A
EXISTING DEMAND LOAD ON PANEL '12-NDP2'	187,200	VA		
NEW CALCULATED LOAD ON PANEL '12-NDP2'	248,056	VA	=	689 A
EXISTING DEMAND LOAD ON SERVICE AND BUILDING 12 SWITCHGEAR	288,000	VA		
NORTH TELECOM ROOMS NORMAL POWER BRANCH FEEDER CALCULATED NEC DEMAND LOAD FROM PANEL SCHEDULES	186,250	VA	=	517 A
TOTAL NEW LOAD ADDED FROM EQUIPMENT BRANCH AND LIFE SAFETY BRANCH SWITCHBOARD '12-EQDP' AND '12-LSDP'	76,288	VA	=	212 A
NEW CALCULATED LOAD ON SERVICE AND BUILDING 12 SWITCHGEAR	364,288	VA	=	1,011 A
EXISTING SERVICE AND DISTRIBUTION EQUIPMENT HAVE ADEQUATE CAPACITY FOR NEW LOAD ADDED.				

Revisions:	Date:

CONSULTANT

A/E:
GDM
1000 W STEUBEN STR, UNIT 3
BINGEN,WA 98605
541.436.4723
ADAM GOODIN, PE

ARCHITECT/ENGINEER OF RECORD

RSA

Engineering, Inc.
MECHANICAL AND ELECTRICAL CONSULTING ENGINEERS
670 West Firweed Lane, Suite 200
Anchorage, AK 99503
Phone (907) 278-0521
Corporate No.: AECC542

STAMP

PROGRAM CONTRACTING ACTIVITY CENTRAL (PCAC)

U.S. Department of Veterans Affairs

DRAWING TITLE

ELECTRICAL LOAD CALCULATIONS

APPROVED: Project Director

PHASE

100% CD FINAL SOLUTION

FLS

FULLY SPRINKLERED

PROJECT TITLE

EHRM INFRASTRUCTURE UPGRADES

LOCATION

HOT SPRINGS, SOUTH DAKOTA

ISSUE DATE

02/22/2022

CHECKED BY

JAM

DRAWN BY

CSZ

PROJECT NUMBER

568A4-21-702

BUILDING NUMBER

N/A

DRAWING NUMBER

EK-119

A


B

C

D

E



F

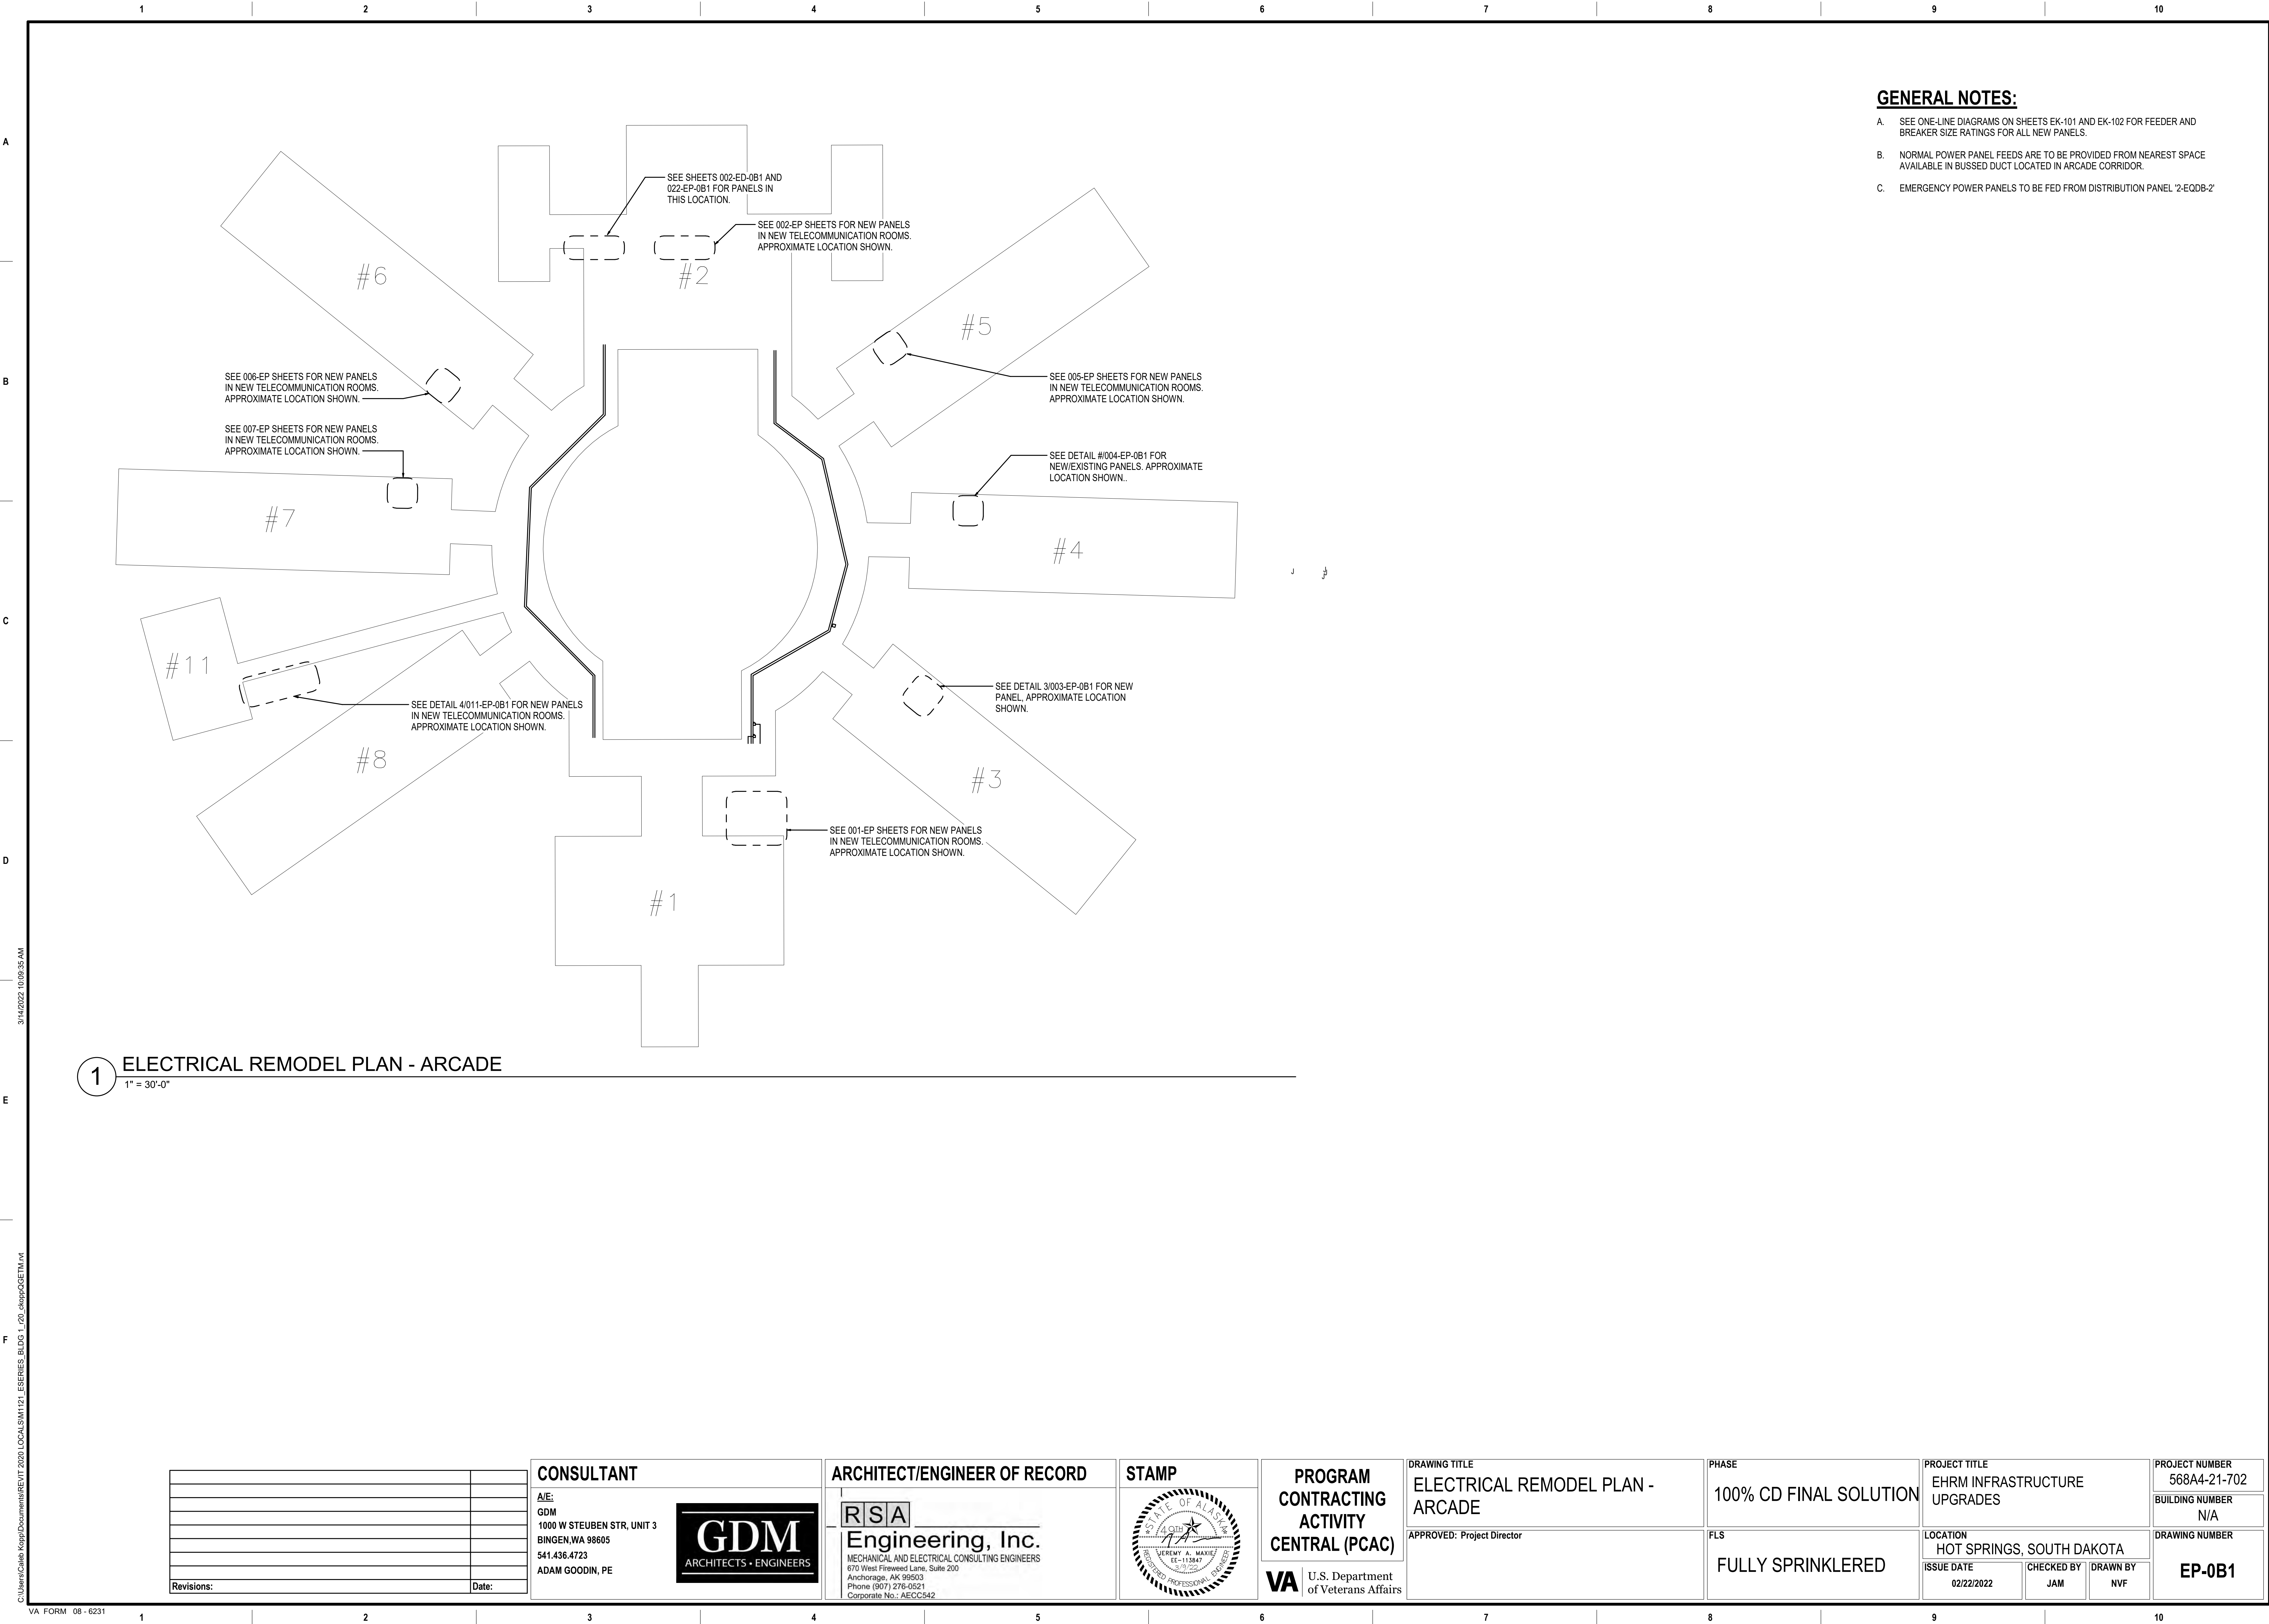


- GENERAL NOTES:**
- A. SEE ONE-LINE DIAGRAMS ON SHEETS EK-101 AND EK-102 FOR FEEDER AND BREAKER SIZE RATINGS FOR ALL NEW PANELS.
 - B. NORMAL POWER PANEL FEEDS ARE TO BE PROVIDED FROM NEAREST SPACE AVAILABLE IN BUSSED DUCT LOCATED IN ARCADE CORRIDOR.
 - C. EMERGENCY POWER PANELS TO BE FED FROM DISTRIBUTION PANEL '2-EQDB-2'

1 ELECTRICAL REMODEL PLAN - ARCADE
1" = 30'-0"


Revisions:		Consultant A/E: GDM 1000 W STEUBEN STR, UNIT 3 BINGEN, WA 98605 541.436.4723 ADAM GOODIN, PE GDM ARCHITECTS • ENGINEERS		Architect/Engineer of Record RSA Engineering, Inc. MECHANICAL AND ELECTRICAL CONSULTING ENGINEERS 670 West Fireweed Lane, Suite 200 Anchorage, AK 99503 Phone (907) 276-0521 Corporate No.: AEC0542 STAMP STATE OF ALASKA 40th JEREMY A. MAXIE 11/13/20 REGISTERED PROFESSIONAL ENGINEER		Program Contracting Activity CENTRAL (PCAC) VA U.S. Department of Veterans Affairs	Drawing Title ELECTRICAL REMODEL PLAN - ARCADE APPROVED: Project Director		Phase 100% CD FINAL SOLUTION FLS FULLY SPRINKLERED		Project Title EHRM INFRASTRUCTURE UPGRADES LOCATION HOT SPRINGS, SOUTH DAKOTA ISSUE DATE 02/22/2022 CHECKED BY JAM DRAWN BY NVF		Project Number 568A4-21-702 BUILDING NUMBER N/A DRAWING NUMBER EP-0B1	
-----------------------	--	---	--	--	--	--	--	--	--	--	---	--	---	--

  


PROJECT TITLE			PROJECT NUMBER		
FIRM INFRASTRUCTURE			568A4-21-702		
GRADES			BUILDING NUMBER		
			N/A		
LOCATION			DRAWING NUMBER		
TODD SPRINGS, SOUTH DAKOTA			001-EP-0B1		
DATE	CHECKED BY	DRAWN BY			
02/22/2022	JAM	CSZ			

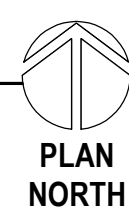

PLAN
NORTH

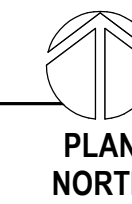

PLAN
NORTH

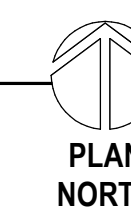

PLAN
NORTH

PROJECT NUMBER
568A4-21-702
BUILDING NUMBER
N/A
DRAWING NUMBER
001-EP-011



PLAN
NORTH



PROJECT NUMBER	568A4-21-702
BUILDING NUMBER	N/A
DRAWING NUMBER	001-EP-021

A

B

C

D

E

F

A


B

C


D

E

F

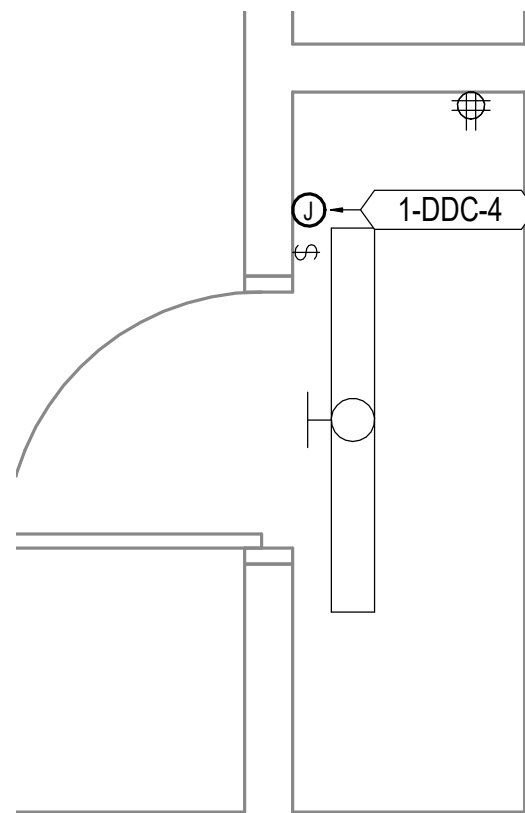


3 ENLARGED ROOM - 306A POWER REMODEL
1/2" = 1'-0"

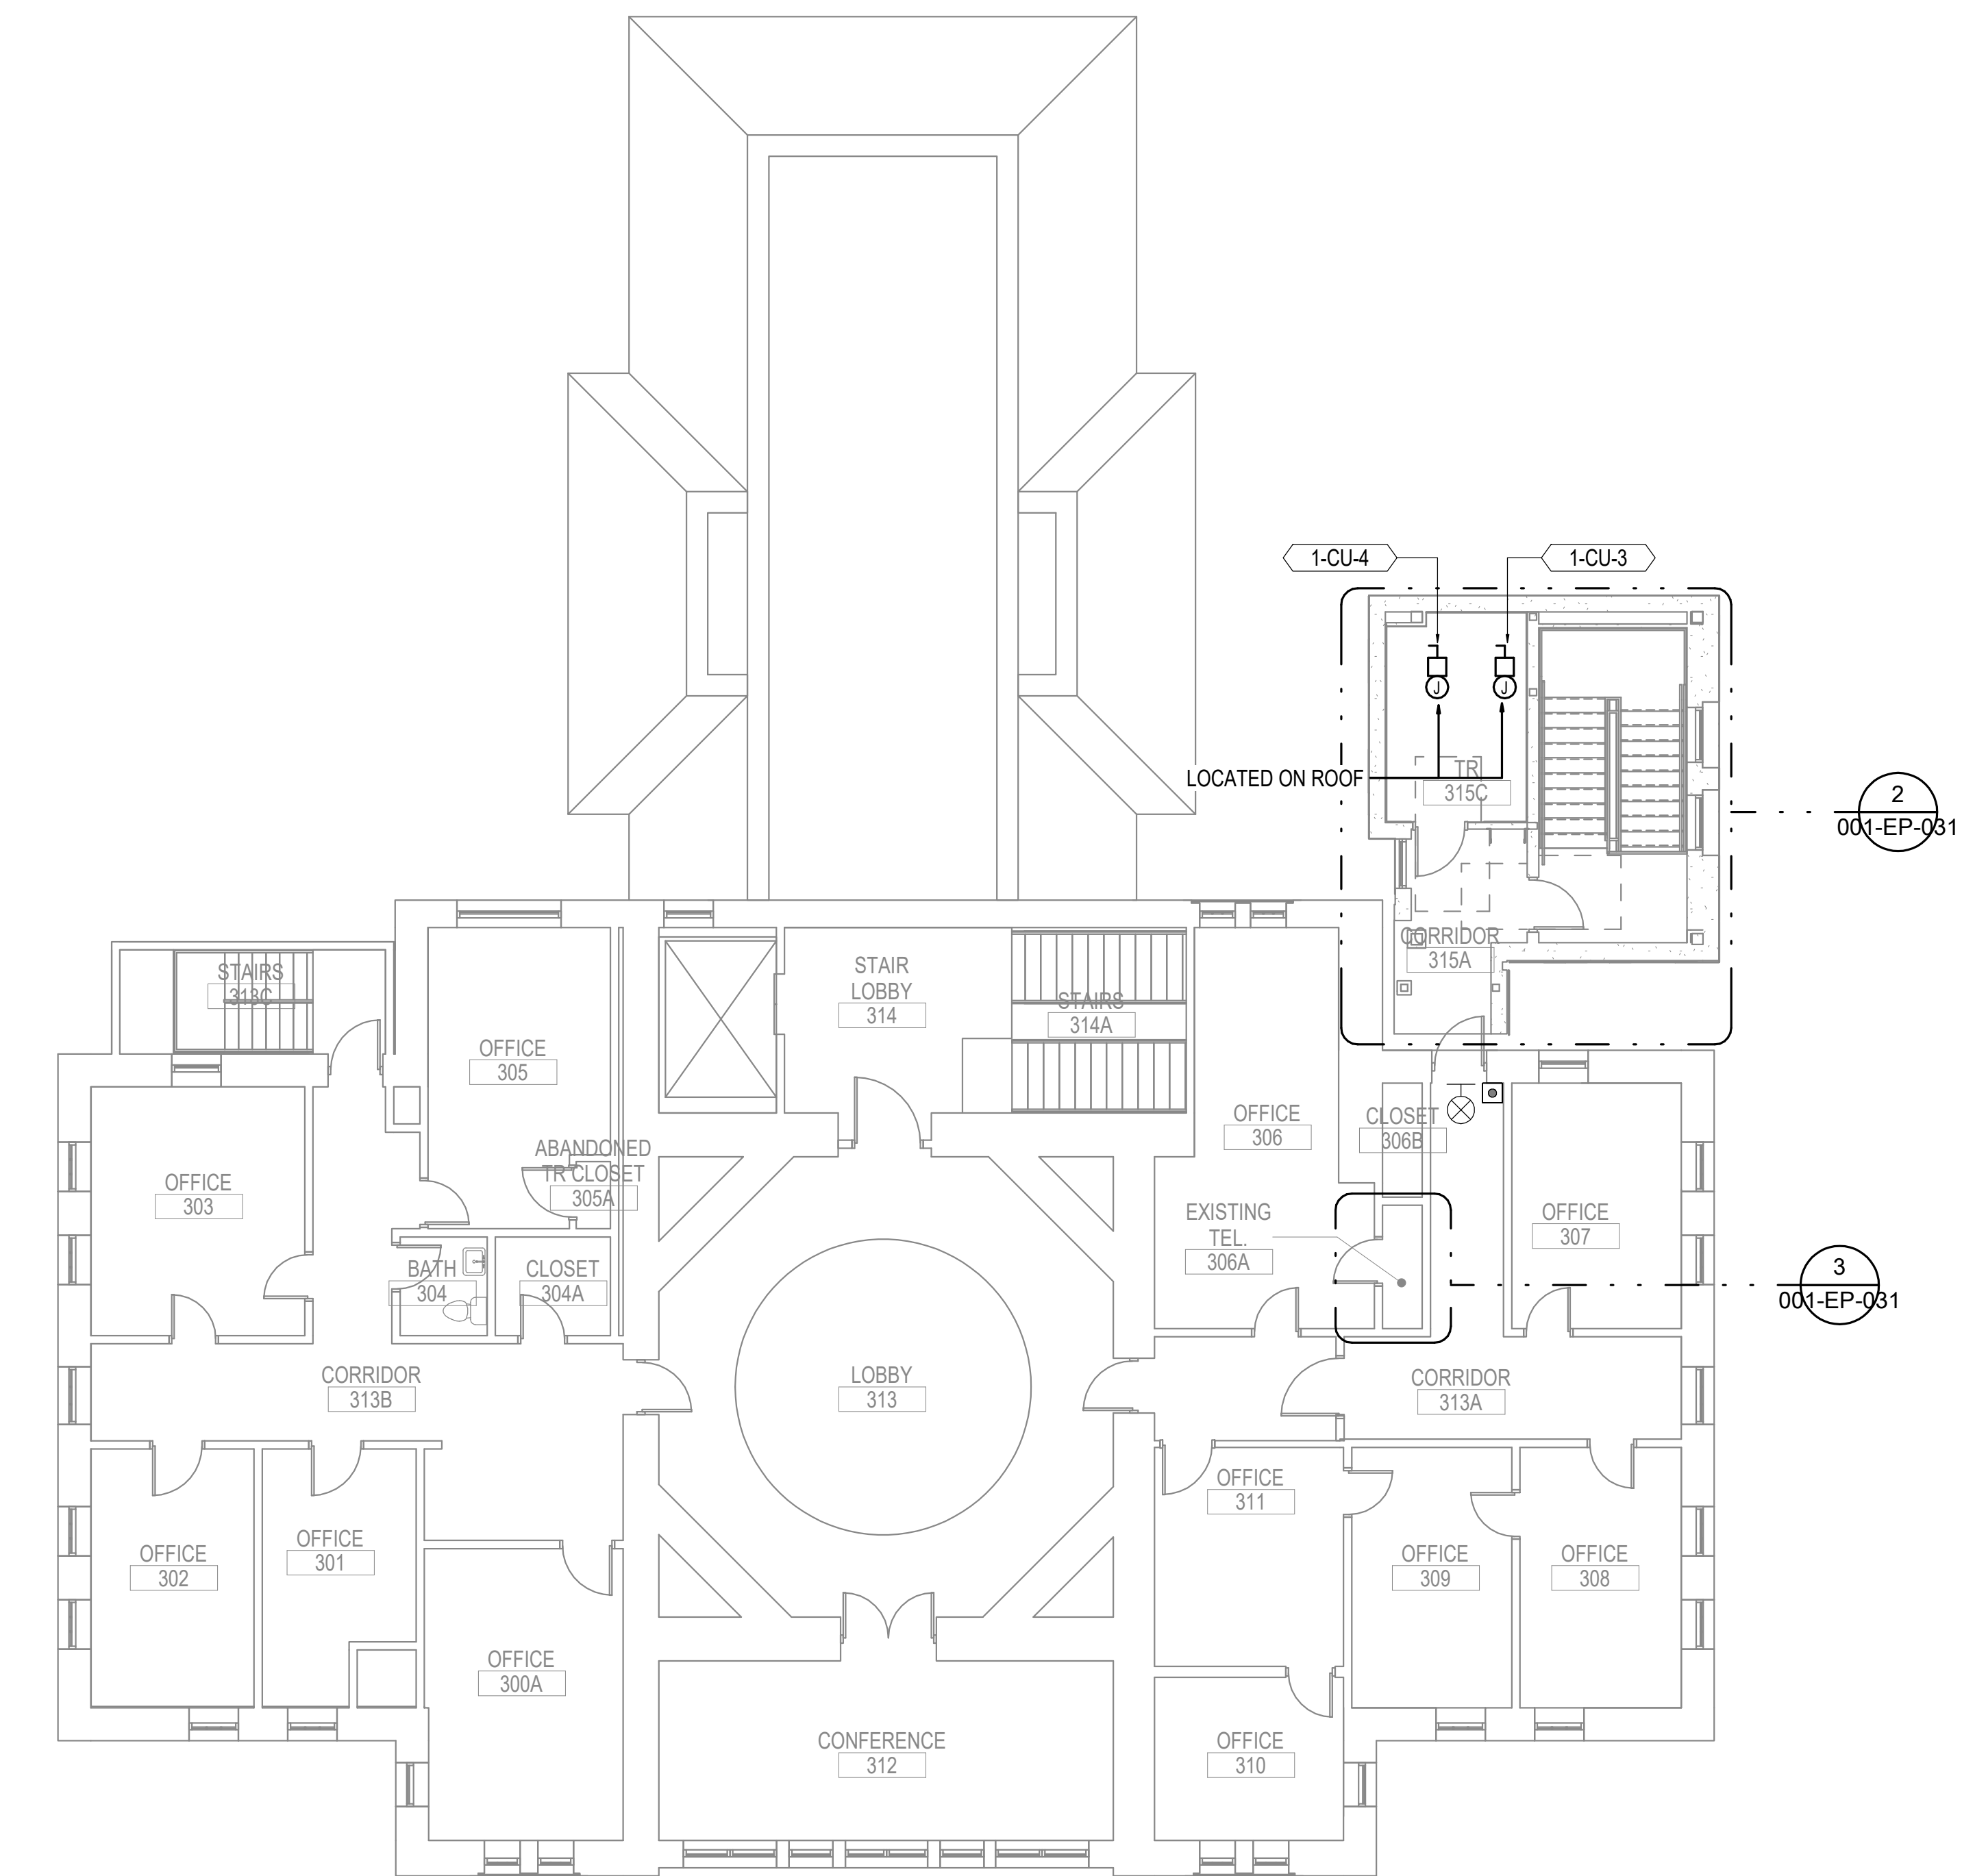


1 ELECTRICAL REMODEL PLAN - BLDG 1 THIRD FLOOR
1/8" = 1'-0"



2 ENLARGED ROOM - 315C POWER REMODEL
1/2" = 1'-0"

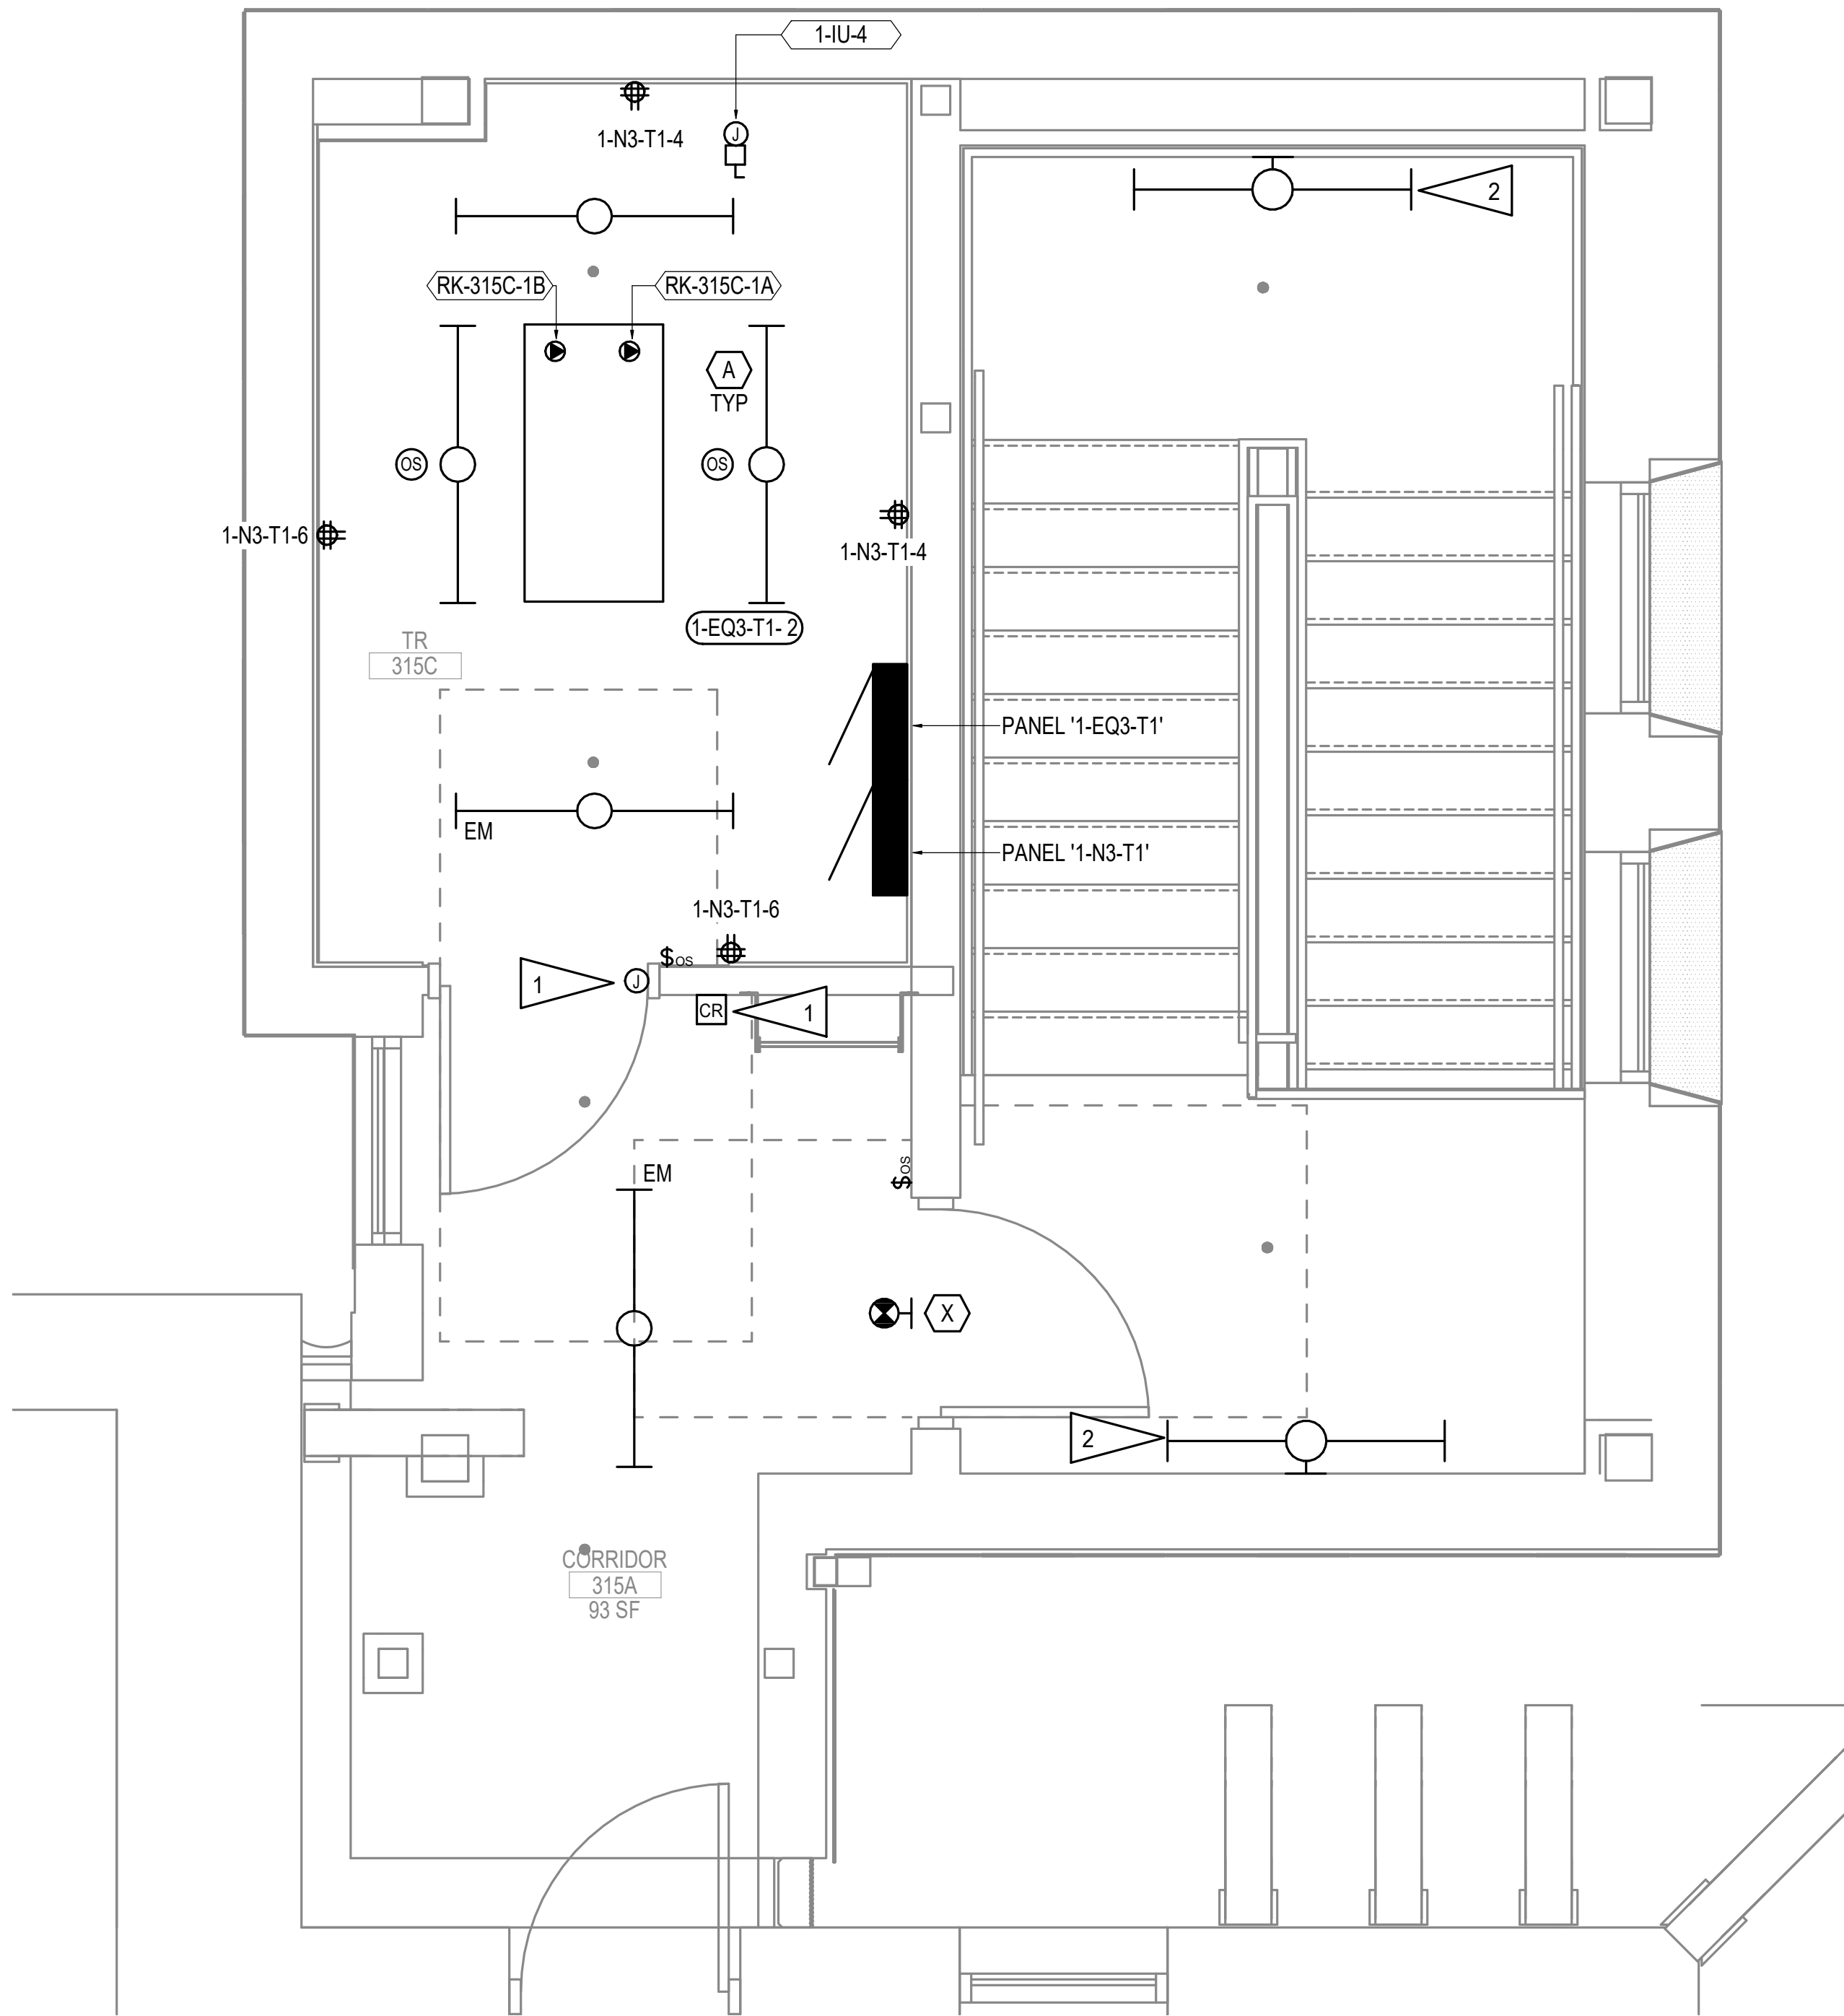

SITE LEGEND

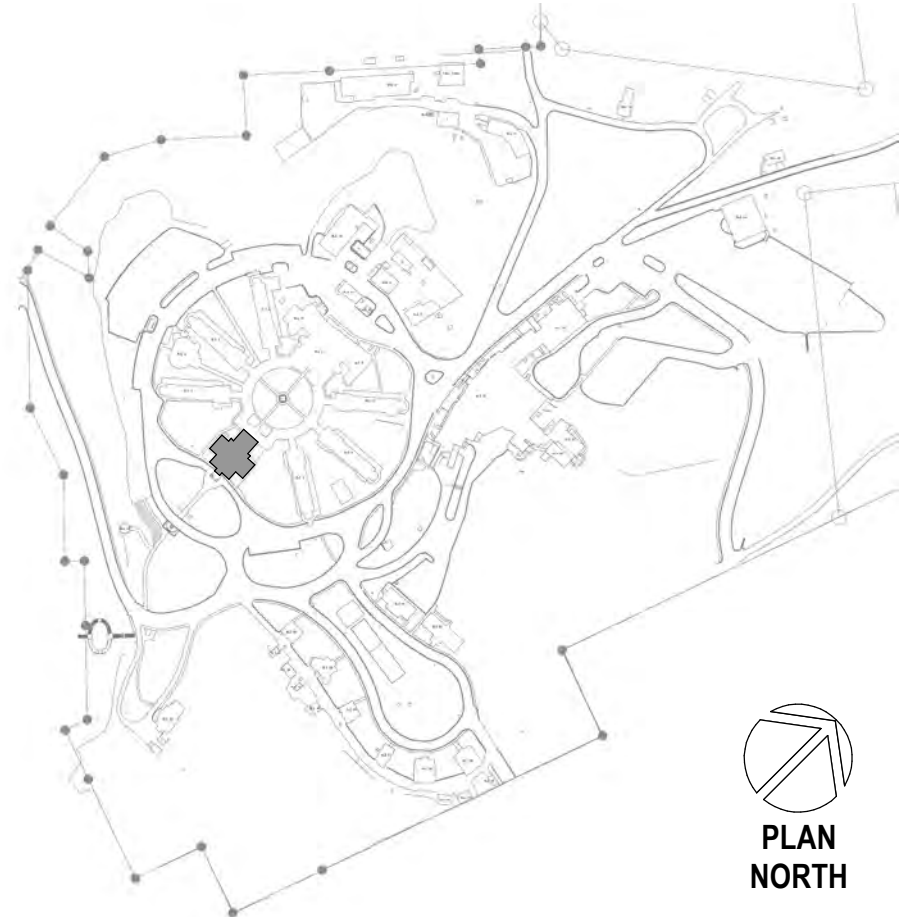


C:\Users\Caleb\AppData\Local\Microsoft\Windows\Temporary Internet Files\Content.IE5\B7QJ6Q1M\121-ESERIES-BLDG-1-201-4.dwg (2/22/2022 1:52:58 PM)

Revisions:	Date:

CONSULTANT
A/E:
GDM
1000 W STEUBEN STR, UNIT 3
BINGEN, WA 98605
541.436.4723
ADAM GOODIN, PE



ARCHITECT/ENGINEER OF RECORD
RSA
Engineering, Inc.
MECHANICAL AND ELECTRICAL CONSULTING ENGINEERS
670 West Fireweed Lane, Suite 200
Anchorage, AK 99503
Phone (907) 278-0521
Corporate No.: AEC0542

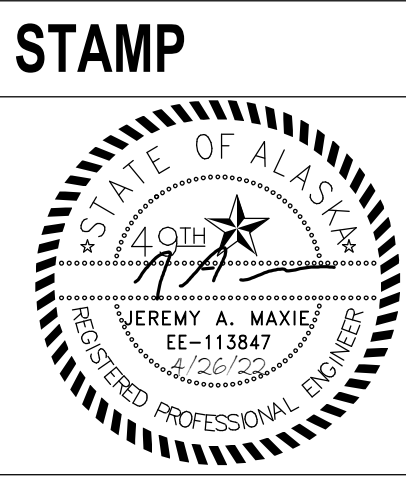

PROGRAM CONTRACTING ACTIVITY CENTRAL (PCAC)
U.S. Department of Veterans Affairs

DRAWING TITLE
ELECTRICAL REMODEL PLAN - BLDG 1 THIRD FLOOR
APPROVED: Project Director

PHASE
100% CD FINAL SOLUTION
FLS
FULLY SPRINKLERED

PROJECT TITLE
EHRM INFRASTRUCTURE UPGRADES
LOCATION
HOT SPRINGS, SOUTH DAKOTA
ISSUE DATE
02/22/2022
CHECKED BY
JAM
DRAWN BY
CSZ

PROJECT NUMBER
568A4-21-702
BUILDING NUMBER
N/A
DRAWING NUMBER
001-EP-031

GENERAL NOTES:


- A. SEE EQUIPMENT SCHEDULE ON THIS SHEET FOR POWER REQUIREMENTS.
- B. COORDINATE LIGHTING LAYOUT WITH RACK AND CABLE TRAY LOCATIONS TO PROVIDE ILLUMINATION ON EQUIPMENT PER LIGHTING DESIGN REQUIREMENTS.
- C. COORDINATE WITH MECHANICAL DRAWINGS FOR EQUIPMENT LOCATIONS AND CONDUIT/PIPE ROUTING PRIOR TO ROUGH-IN.
- D. SEE SHEETS EK-101 AND EK-102 FOR POWER ONE-LINE DIAGRAMS.

SHEET NOTES:


1. PROVIDE RACEWAY AND BOXES FOR ACCESS CONTROLS SYSTEM COMPONENTS. SEE EK-106 FOR TYPICAL DOOR DETAIL.

EQUIPMENT SCHEDULE - BUILDING 2

ID TAG	EQUIPMENT DESCRIPTION	ELECTRICAL DATA						REQUIRES DISCONNECT	PANEL / CIRCUIT	CONDUIT / CONDUCTOR SIZE	NOTES
		HP	AMP	WATT	VA	VOLT	Φ				
2-IU-1	AC INDOOR UNIT	-	30	-	-	208	1	X	2-NB-T1-7,9	0.75" C, 2#8, 1#10 GND	INTEGRAL CONTROLLER
2-IU-2	AC INDOOR UNIT	-	37.5	-	-	208	1	X	2-N2-1-28,30	0.75" C, 2#6, 1#10 GND	INTEGRAL CONTROLLER
2-CU-1	CONDENSING UNIT	-	20.5	-	-	208	1	X	2-NB-T1-11,13	0.75" C, 2#10, 1#10 GND	INTEGRAL CONTROLLER
2-CU-2	CONDENSING UNIT	-	20.5	-	-	208	1	X	2-N2-1-27,29	0.75" C, 2#10, 1#10 GND	INTEGRAL CONTROLLER
2-DDC-1	DDC FOR INDOOR UNIT	-	-	50	-	120	1	N/A	2-EQB-T1-4	0.75" C, 1#12, 1#12 NEUT, 1#12 GND	COORDINATE WITH MECH FOR LOCATION
2-DDC-2	DDC FOR INDOOR UNIT	-	-	50	-	120	1	N/A	2-EQ2-1-4	0.75" C, 1#12, 1#12 NEUT, 1#12 GND	COORDINATE WITH MECH FOR LOCATION
RK-B1B-1A	TELECOM RACK RECEPTACLE	-	-	5000	-	208	3	N/A	2-EQB-T1-1,3,5	0.75" C, 3#12, 1#10 NEUT, 1#12 GND	PROVIDE NEMA I21-20R, SEE 5/000-I-001
RK-B1B-1B	TELECOM RACK RECEPTACLE	-	-	5000	-	208	3	N/A	2-NB-T1-1,3,5	0.75" C, 3#12, 1#10 NEUT, 1#12 GND	PROVIDE NEMA I21-20R, SEE 5/000-I-001
RK-222-1A	TELECOM RACK RECEPTACLE	-	-	5000	-	208	3	N/A	2-EQ2-T1-1,3,5	0.75" C, 3#12, 1#10 NEUT, 1#12 GND	PROVIDE NEMA I21-20R, SEE 5/000-I-001
RK-222-1B	TELECOM RACK RECEPTACLE	-	-	5000	-	208	3	N/A	2-N2-1-19,21,23	0.75" C, 3#12, 1#10 NEUT, 1#12 GND	PROVIDE NEMA I21-20R, SEE 5/000-I-001
2-RECP-1	CONVENIENCE RECEPTACLE BASEMENT	-	-	-	180	120	1	N/A	2-NB-T1-2	0.75" C, 2#12, 1#12 GND	PROVIDE GFCI, WEATHERPROOF CONVENIENCE RECEPTACLE
2-RECP-2	CONVENIENCE RECEPTACLE ROOFTOP	-	-	-	180	120	1	N/A	2-N2-1-18	0.75" C, 2#12, 1#12 GND	PROVIDE GFCI, WEATHERPROOF CONVENIENCE RECEPTACLE

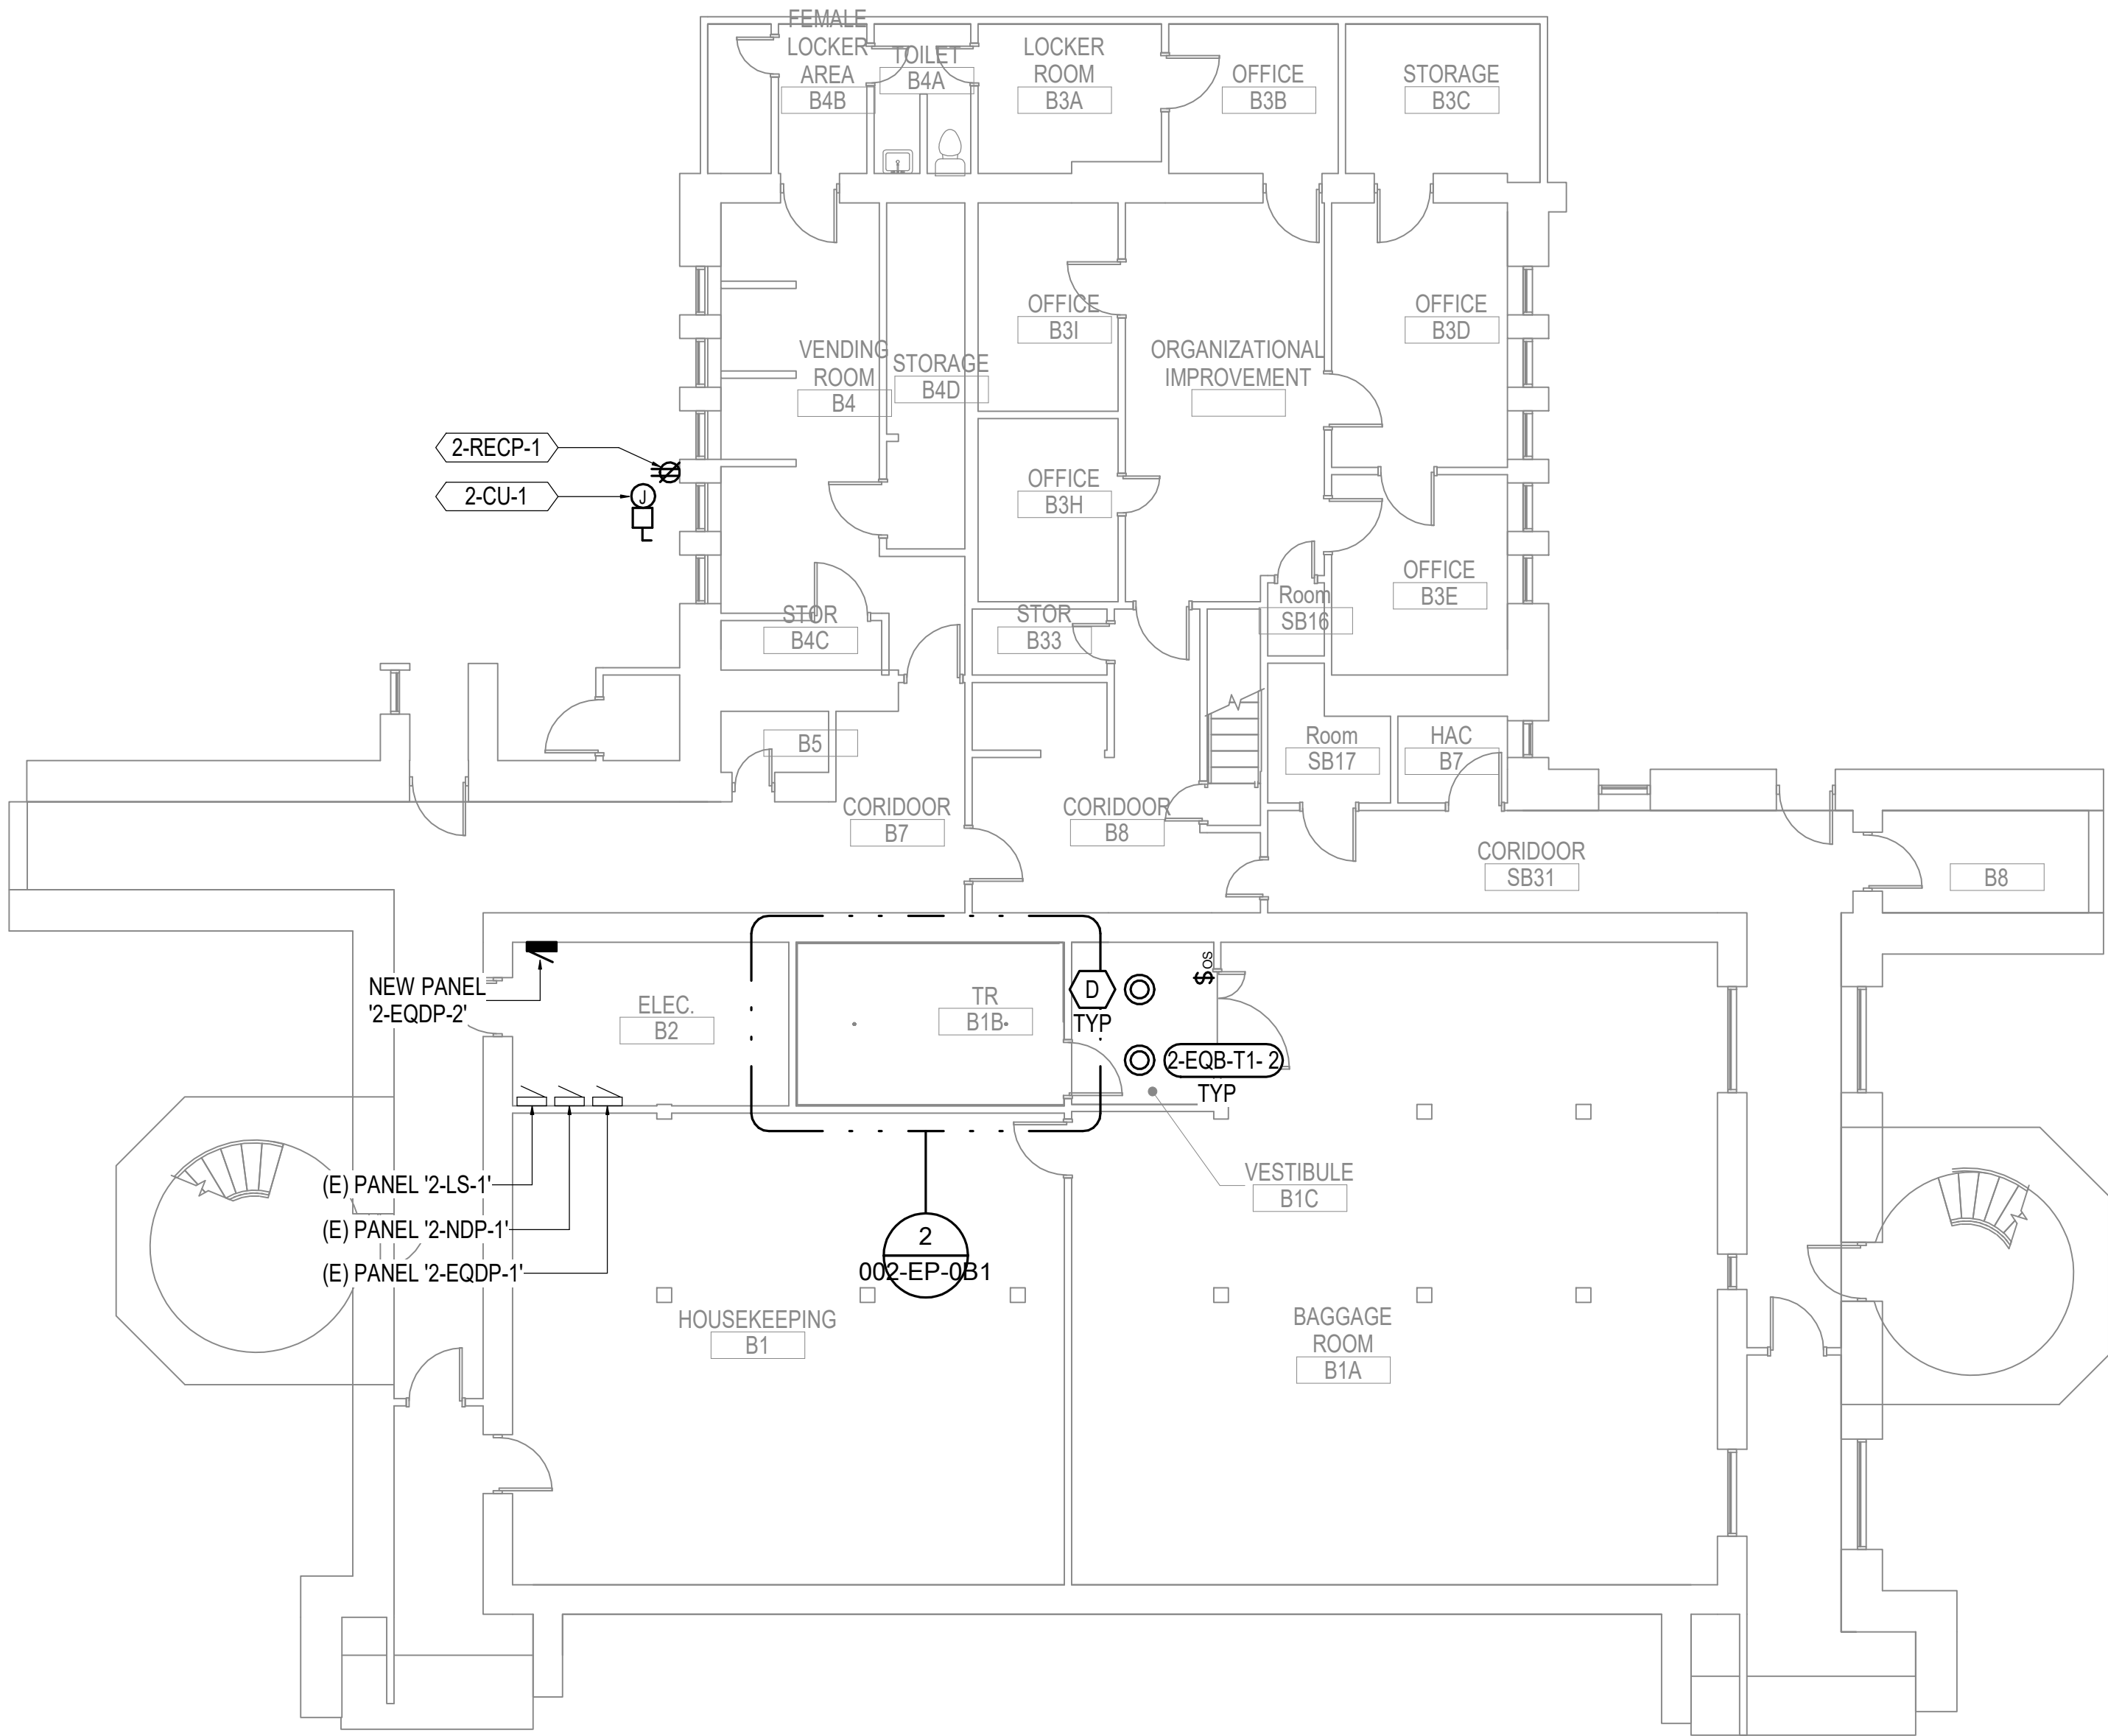


1 ELECTRICAL REMODEL PLAN - BLDG 2 BASEMENT
1/8" = 1'-0"

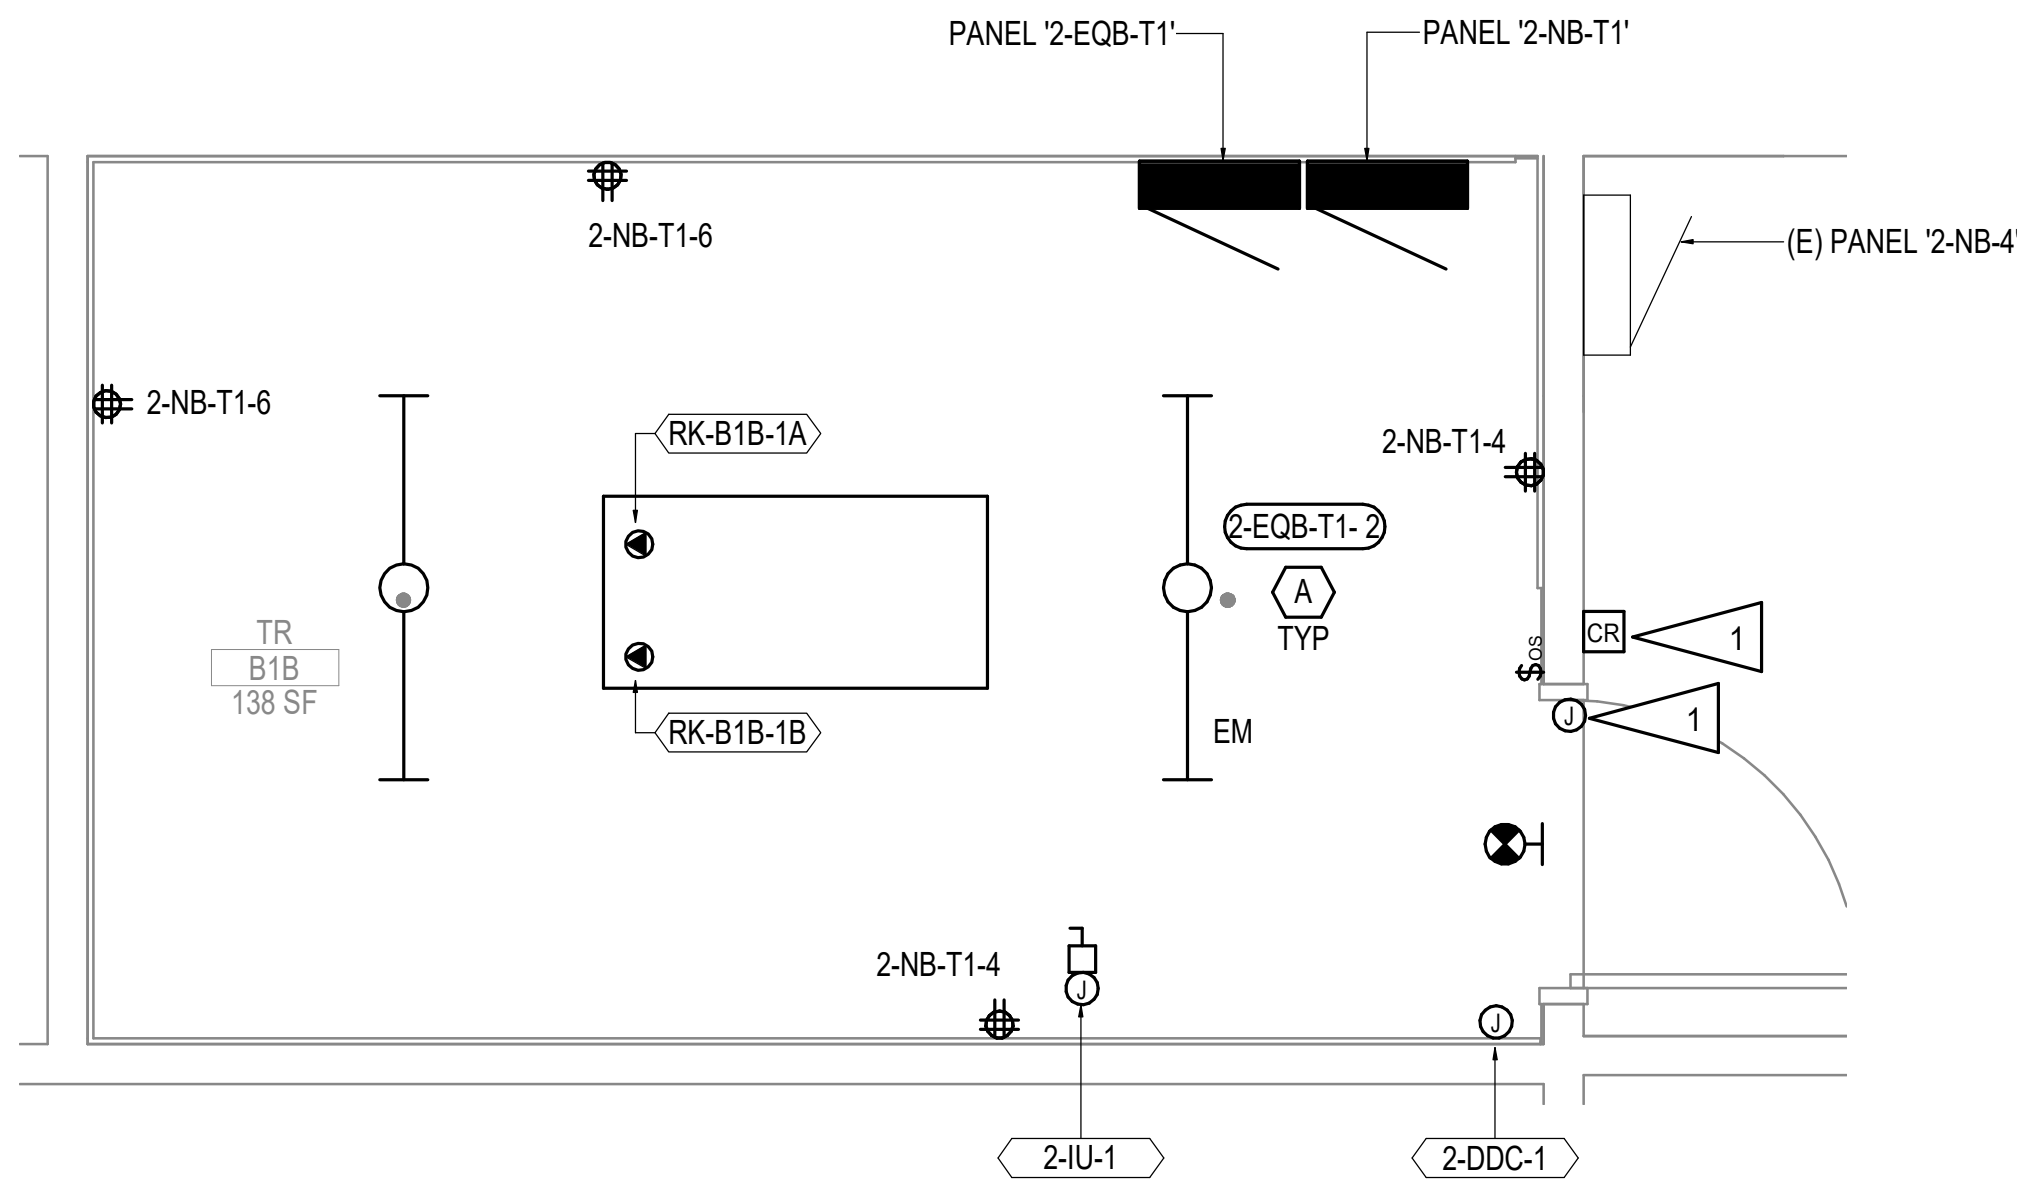

2 ENLARGED ROOM - B1B ELECTRICAL REMODEL
1/2" = 1'-0"

SITE LEGEND

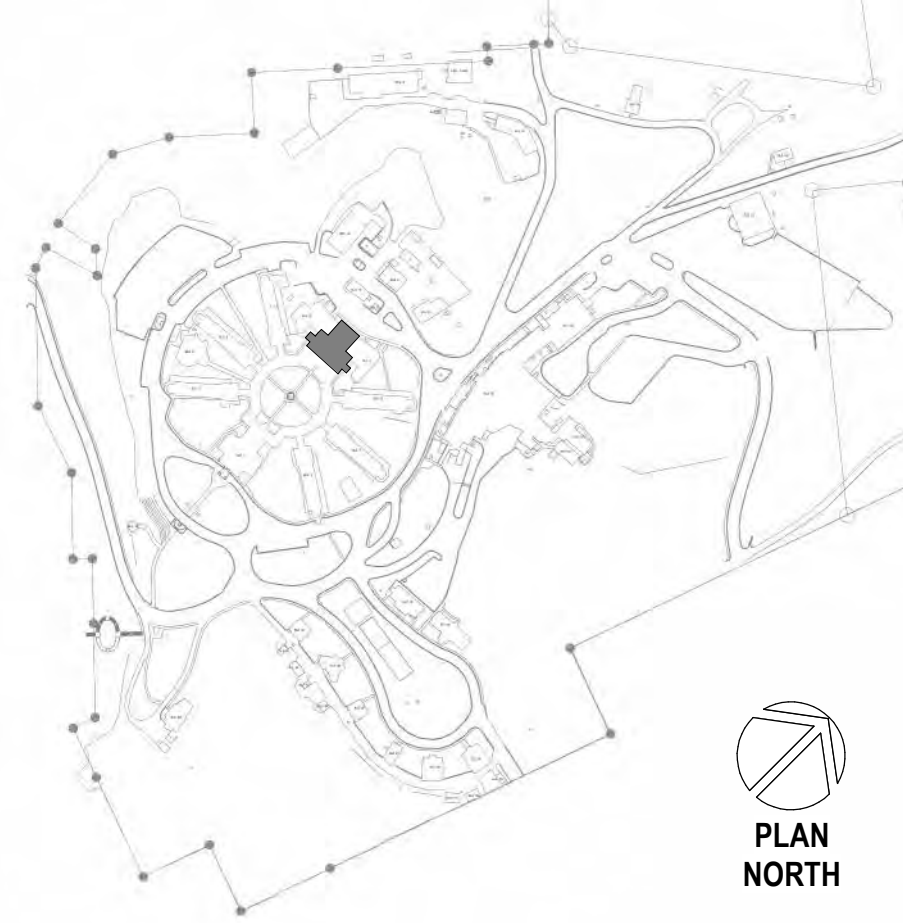

Revisions:	Date:

CONSULTANT

A/E:
GDM
1000 W STEUBEN ST, UNIT 3
BINGEN, WA 98605
541.436.4723
ADAM GOODIN, PE

GDM
ARCHITECTS • ENGINEERS

ARCHITECT/ENGINEER OF RECORD

RSA
Engineering, Inc.
MECHANICAL AND ELECTRICAL CONSULTING ENGINEERS
670 West Fireweed Lane, Suite 200
Anchorage, AK 99503
Phone (907) 278-0521
Corporate No.: AEC0542

STAMP

STATE OF ALASKA
JEREMY A. MAXIE
E.E.-111847
REGISTERED PROFESSIONAL ENGINEER

PROGRAM CONTRACTING ACTIVITY CENTRAL (PCAC)

VA U.S. Department of Veterans Affairs

DRAWING TITLE
ELECTRICAL REMODEL PLAN - BLDG 2 BASEMENT

APPROVED: Project Director

PHASE
100% CD FINAL SOLUTION

FLS
FULLY SPRINKLERED

PROJECT TITLE
EHRM INFRASTRUCTURE UPGRADES

LOCATION
HOT SPRINGS, SOUTH DAKOTA

ISSUE DATE
2/22/2022

CHECKED BY
JAM

DRAWN BY
CSZ

PROJECT NUMBER
568A4-21-702

BUILDING NUMBER
02

DRAWING NUMBER
002-EP-0B1


 
C:\Users\Caleb\AppData\Local\Microsoft\REVIT\2020\LOCALS\1121\ESERIES_BLDG 2-021.dwg 2/22/2022 5:40:17 PM

GENERAL NOTES:


- A. SEE EQUIPMENT SCHEDULE ON SHEET 002-EP-0B1 FOR POWER REQUIREMENTS.
- B. COORDINATE LIGHTING LAYOUT WITH RACK AND CABLE TRAY LOCATIONS TO PROVIDE ILLUMINATION ON EQUIPMENT PER LIGHTING DESIGN REQUIREMENTS.
- C. COORDINATE WITH MECHANICAL DRAWINGS FOR EQUIPMENT LOCATIONS AND CONDUIT/PIPE ROUTING PRIOR TO ROUGH-IN.

SHEET NOTES:

1. PROVIDE RACEWAY AND BOXES FOR ACCESS CONTROLS SYSTEM COMPONENTS. SEE EK-106 FOR TYPICAL DOOR DETAIL.

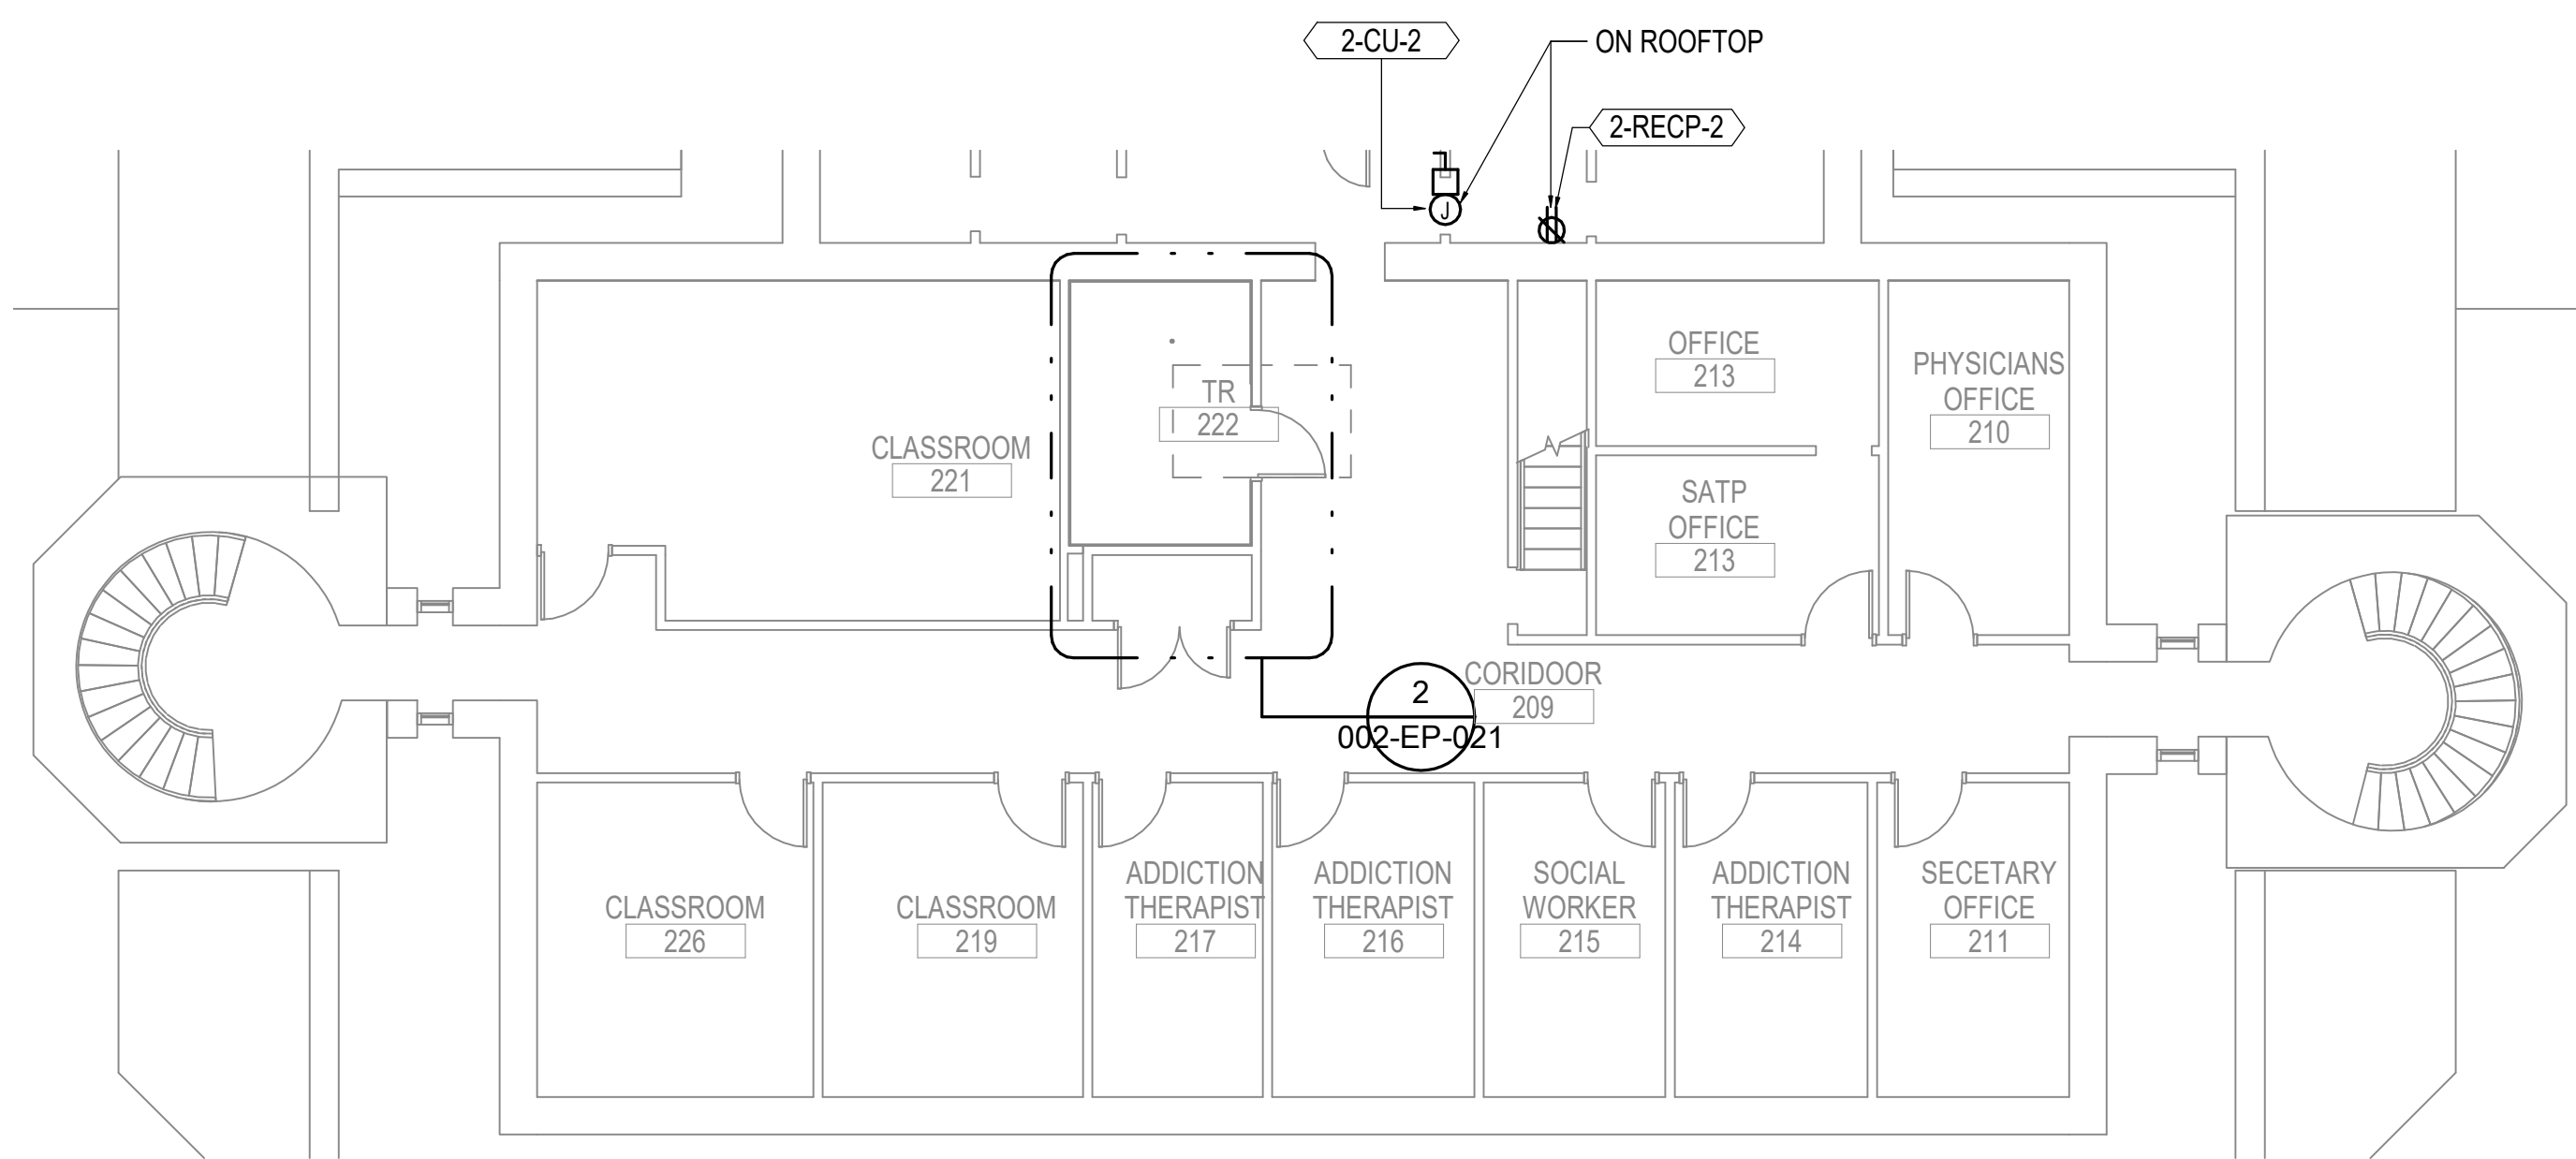


1 ELECTRICAL REMODEL PLAN - BLDG 2 SECOND FLOOR
1/8" = 1'-0"

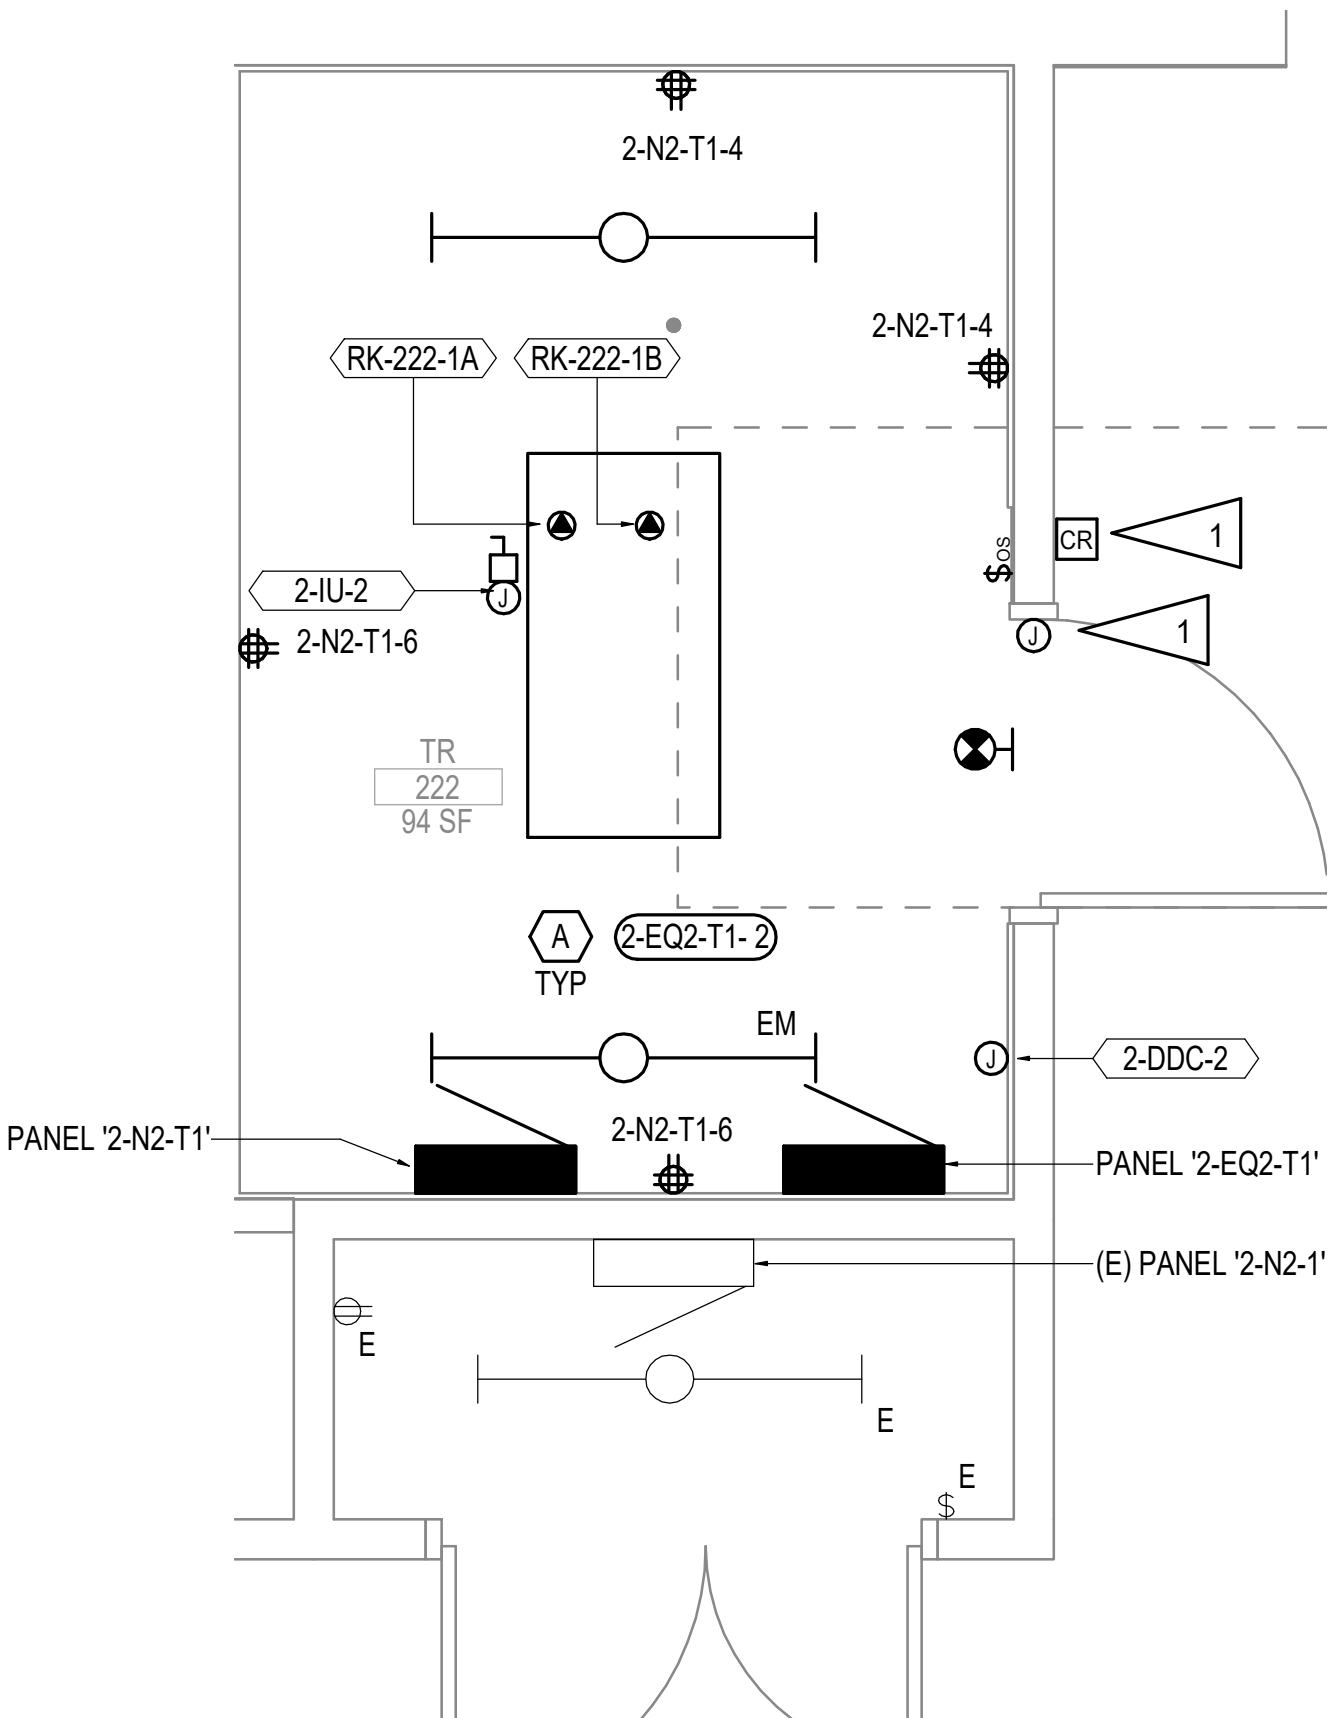

2 ENLARGED ROOM - 222 ELECTRICAL REMODEL
1/2" = 1'-0"



SITE LEGEND

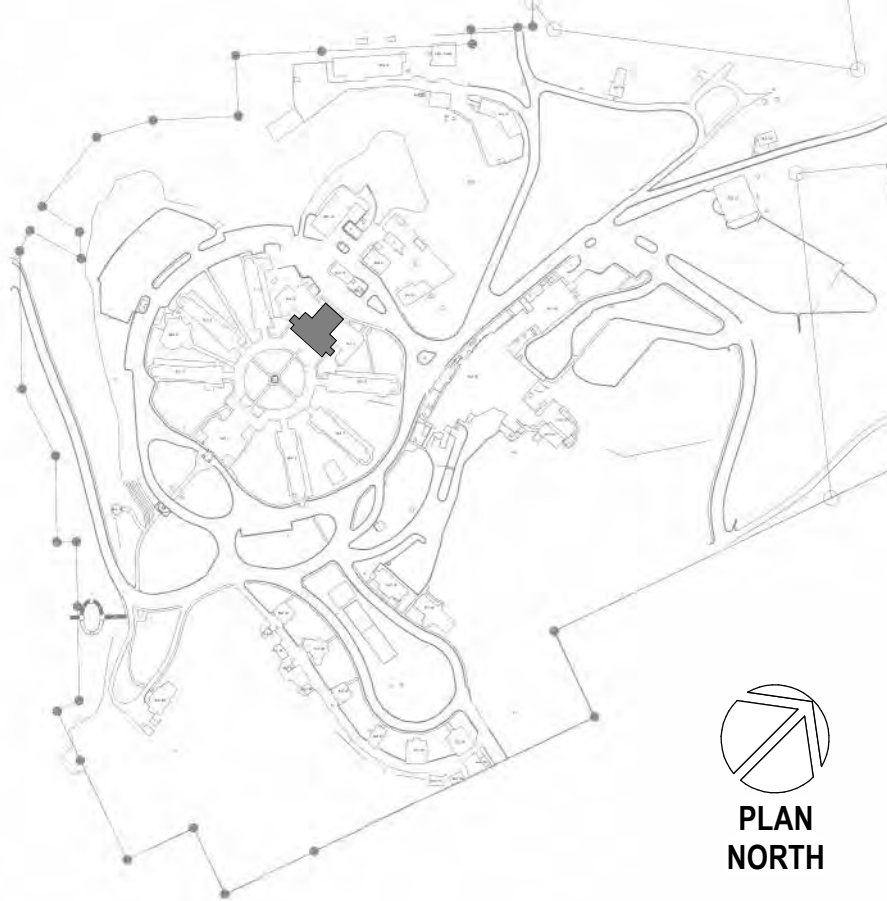

Revisions:	Date:

CONSULTANT

A/E:
GDM
1000 W STEUBEN ST, UNIT 3
BINGEN, WA 98605
541.436.4723
ADAM GOODIN, PE

GDM
ARCHITECTS • ENGINEERS

ARCHITECT/ENGINEER OF RECORD

RSA
Engineering, Inc.
MECHANICAL AND ELECTRICAL CONSULTING ENGINEERS
670 West Firwood Lane, Suite 200
Anchorage, AK 99503
Phone (907) 278-0521
Corporate No.: AEC0542

STAMP

STATE OF ALASKA
JEREMY A. MAXIE
EE-113847
REGISTERED PROFESSIONAL ENGINEER

PROGRAM CONTRACTING ACTIVITY CENTRAL (PCAC)

VA U.S. Department of Veterans Affairs

DRAWING TITLE
ELECTRICAL REMODEL PLAN - BLDG 2 SECOND FLOOR

APPROVED: Project Director

PHASE
100% CD FINAL SOLUTION

FLS
FULLY SPRINKLERED

PROJECT TITLE
EHRM INFRASTRUCTURE UPGRADES

LOCATION
HOT SPRINGS, SOUTH DAKOTA

ISSUE DATE
2/22/2022

CHECKED BY
JAM

DRAWN BY
CSZ

PROJECT NUMBER
568A4-21-702

BUILDING NUMBER
02

DRAWING NUMBER
002-EP-021

EQUIPMENT SCHEDULE - BUILDING 3


ID TAG	EQUIPMENT DESCRIPTION	ELECTRICAL DATA						REQUIRES DISCONNECT	PANEL / CIRCUIT	CONDUIT / CONDUCTOR SIZE	NOTES
		HP	AMP	WATT	VA	VOLT	Ø				
3-IU-1	AC INDOOR UNIT	-	30	-	-	208	1	X	3-N1-T1-7,9	0.75" C, 2#8, 1#10 GND	INTEGRAL CONTROLLER
3-CU-1	CONDENSING UNIT	-	20.5	-	-	208	1	X	3-N1-T1-11,13	0.75" C, 2#10, 1#10 GND	INTEGRAL CONTROLLER
3-DDC-1	DDC FOR INDOOR UNIT	-	-	50	-	120	1	N/A	3-EQ1-T1-4	0.75" C, 1#12, 1#12 NEUT, 1#12 GND	COORDINATE WITH MECH FOR LOCATION
RK-103-1A	TELECOM RACK RECEPTACLE	-	-	10000	-	208	3	N/A	3-EQ1-T1-1,3,5	0.75" C, 3#10, 1#8 NEUT, 1#10 GND	PROVIDE NEMA L21-30R, SEE 5/000-I-001
RK-103-1B	TELECOM RACK RECEPTACLE	-	-	10000	-	208	3	N/A	3-N1-T1-1,3,5	0.75" C, 3#10, 1#8 NEUT, 1#10 GND	PROVIDE NEMA L21-30R, SEE 5/000-I-001
3-RECP-1	CONVENIENCE RECEPTACLE	-	-	-	180	120	1	N/A	3-N1-T1-8	0.75" C, 2#12, 1#12 GND	PROVIDE GFCI, WEATHERPROOF CONVENIENCE RECEPTACLE

GENERAL NOTES:


- A. SEE EQUIPMENT SCHEDULE ON THIS SHEET FOR POWER REQUIREMENTS.
- B. COORDINATE LIGHTING LAYOUT WITH RACK AND CABLE TRAY LOCATIONS TO PROVIDE ILLUMINATION ON EQUIPMENT PER LIGHTING DESIGN REQUIREMENTS.
- C. COORDINATE WITH MECHANICAL DRAWINGS FOR EQUIPMENT LOCATIONS AND CONDUIT/PIPE ROUTING PRIOR TO ROUGH-IN.

SHEET NOTES:


1. PROVIDE RACEWAY AND BOXES FOR ACCESS CONTROLS SYSTEM COMPONENTS. SEE EK-104 FOR TYPICAL DOOR DETAIL.

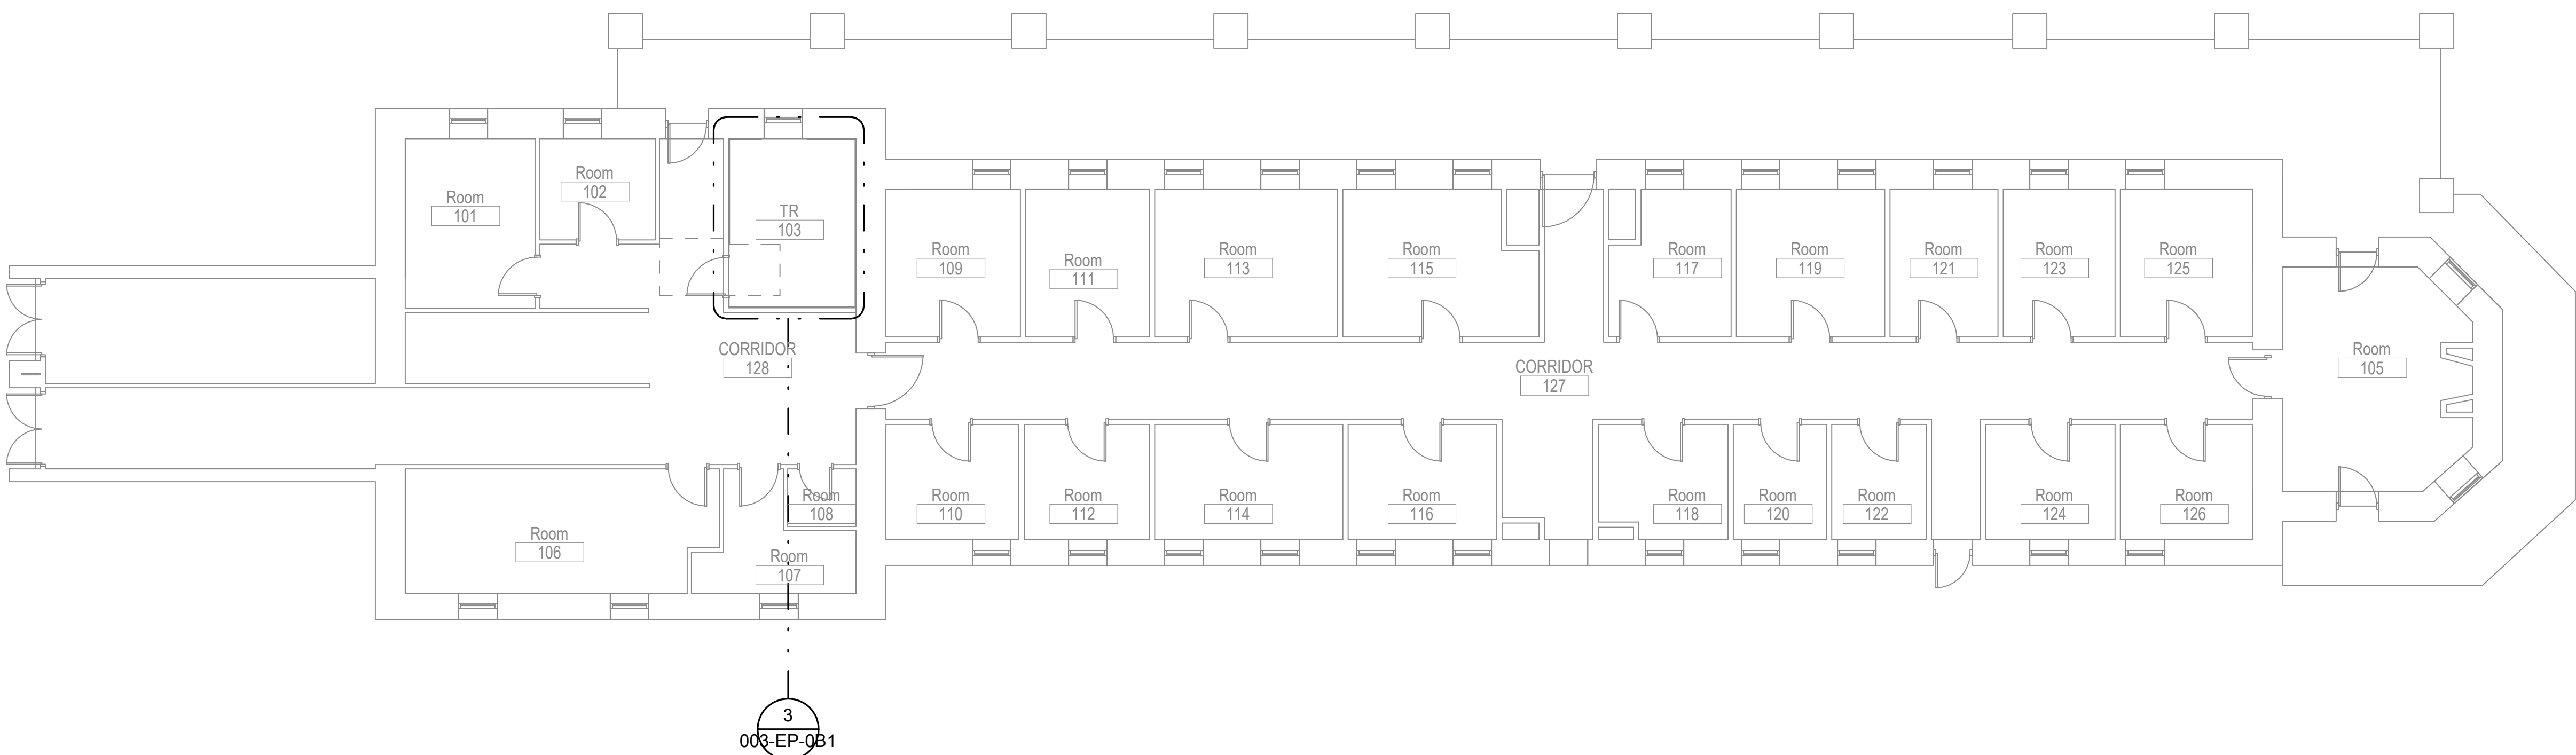

2 ELECTRICAL REMODEL - BLDG 3 FIRST FLOOR
1/8" = 1'-0"

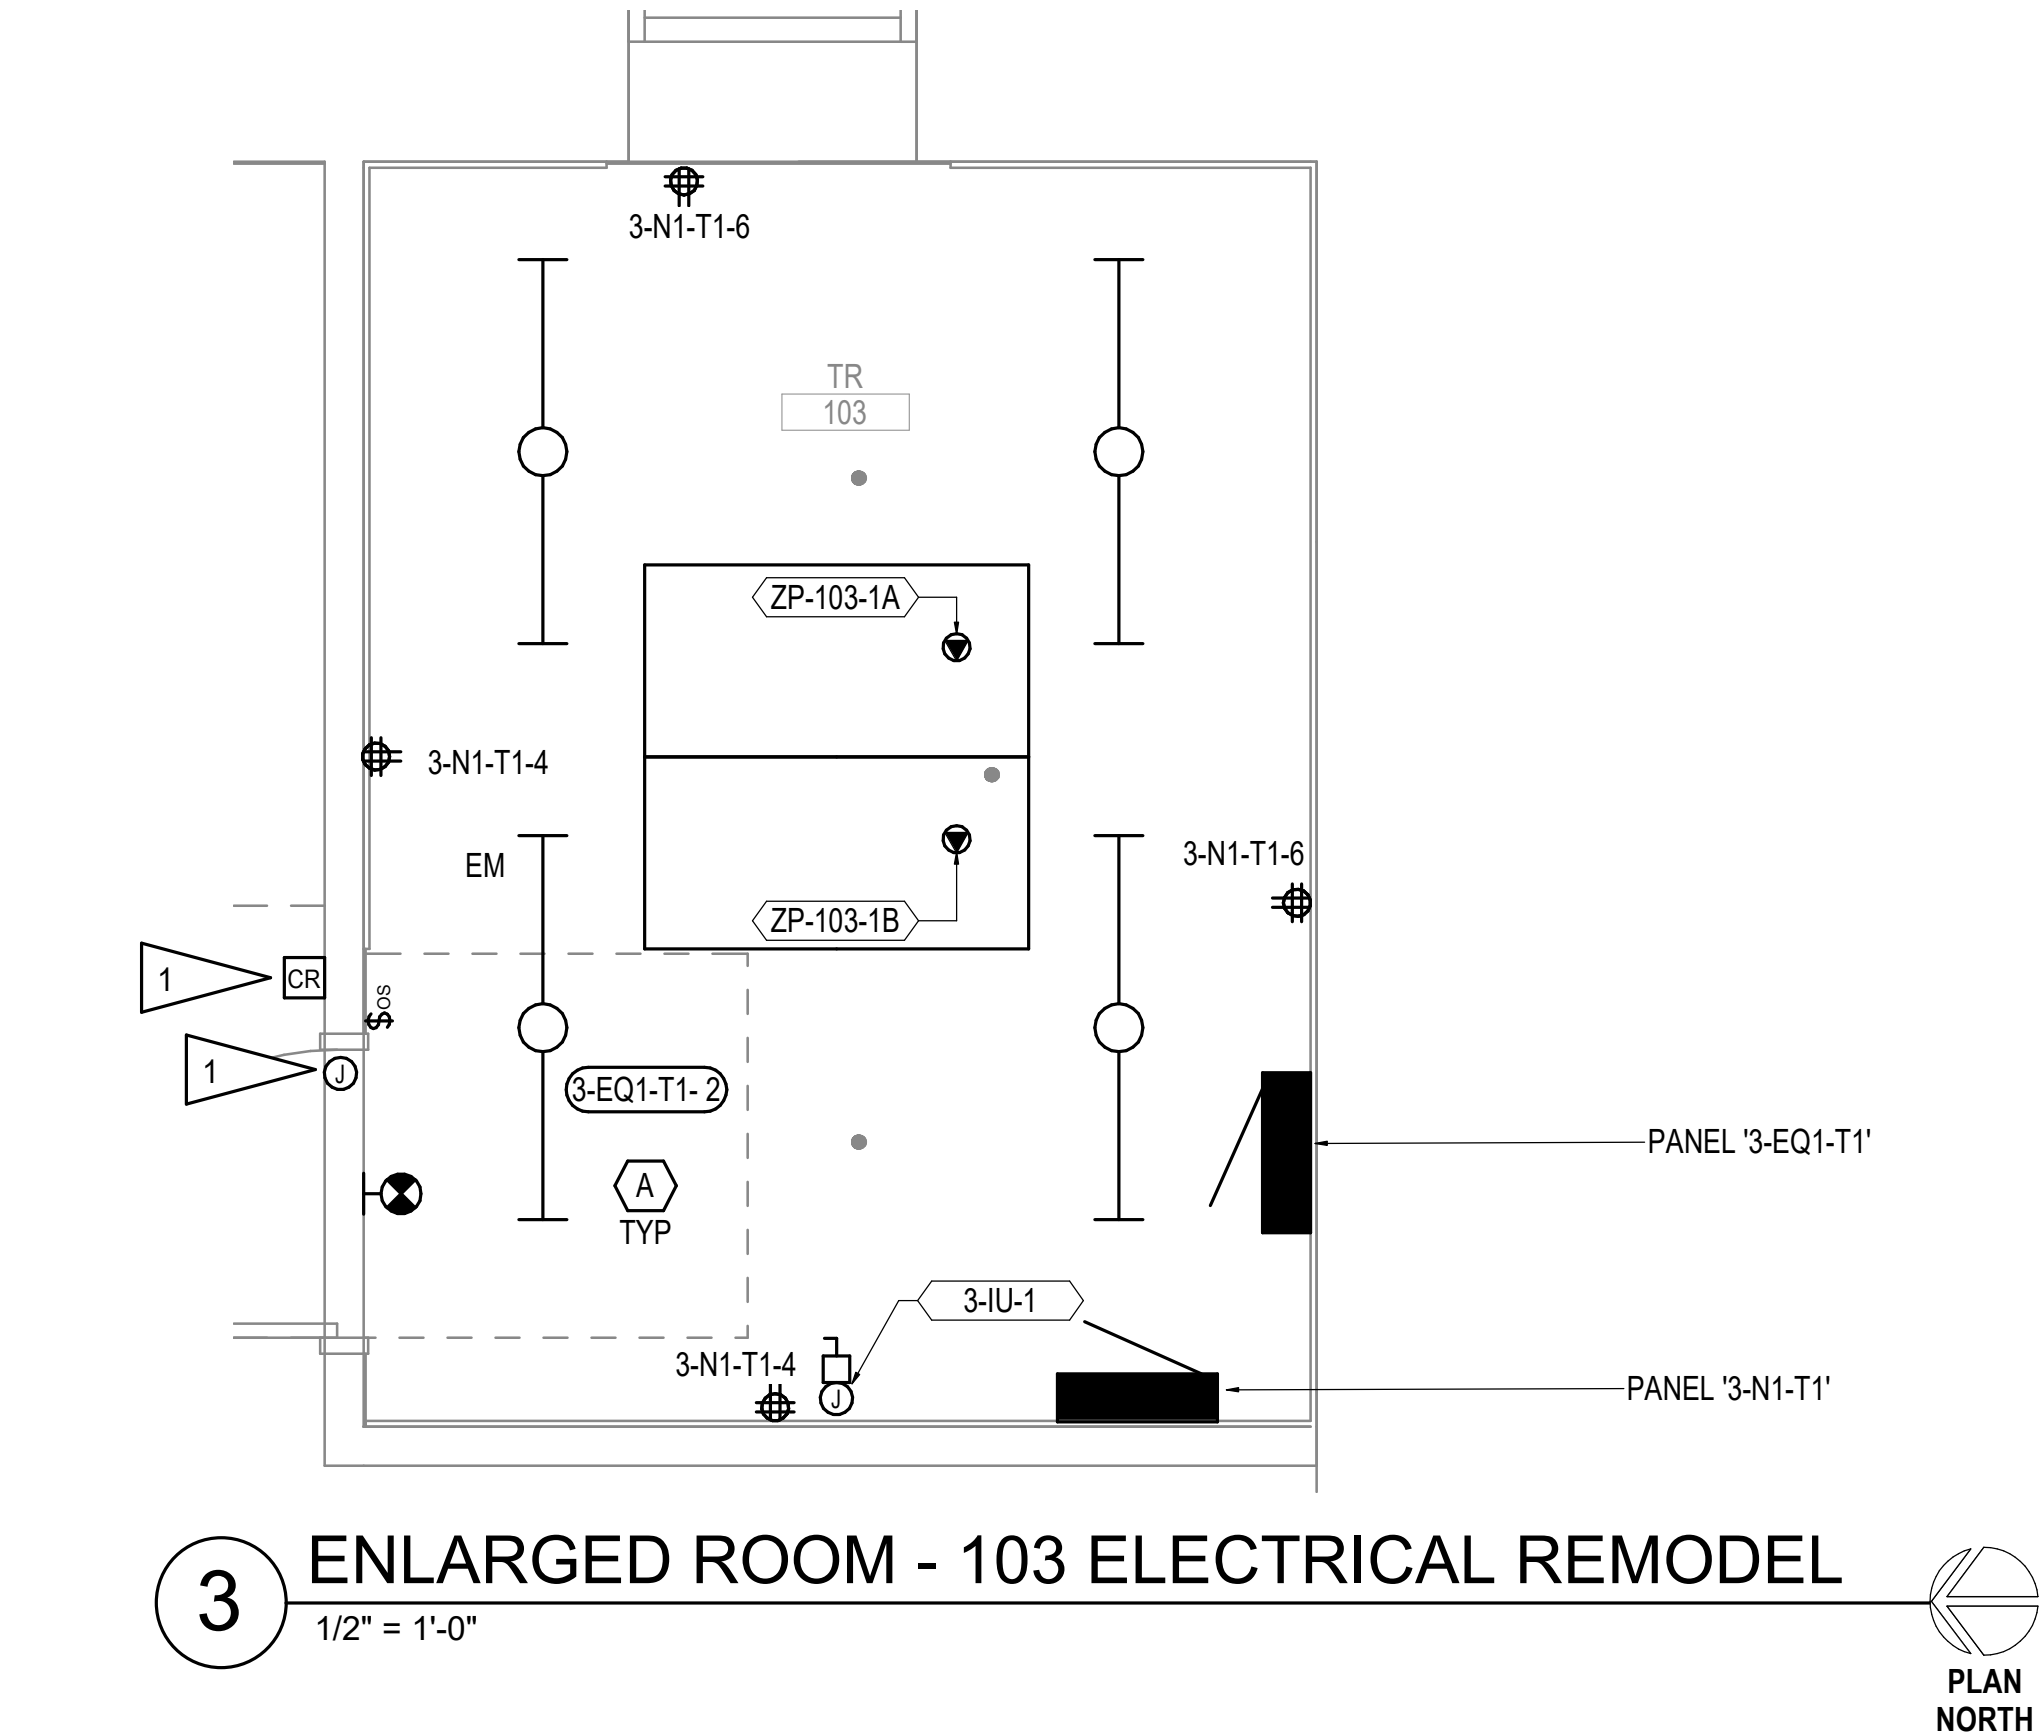


3 ENLARGED ROOM - 103 ELECTRICAL REMODEL
1/2" = 1'-0"

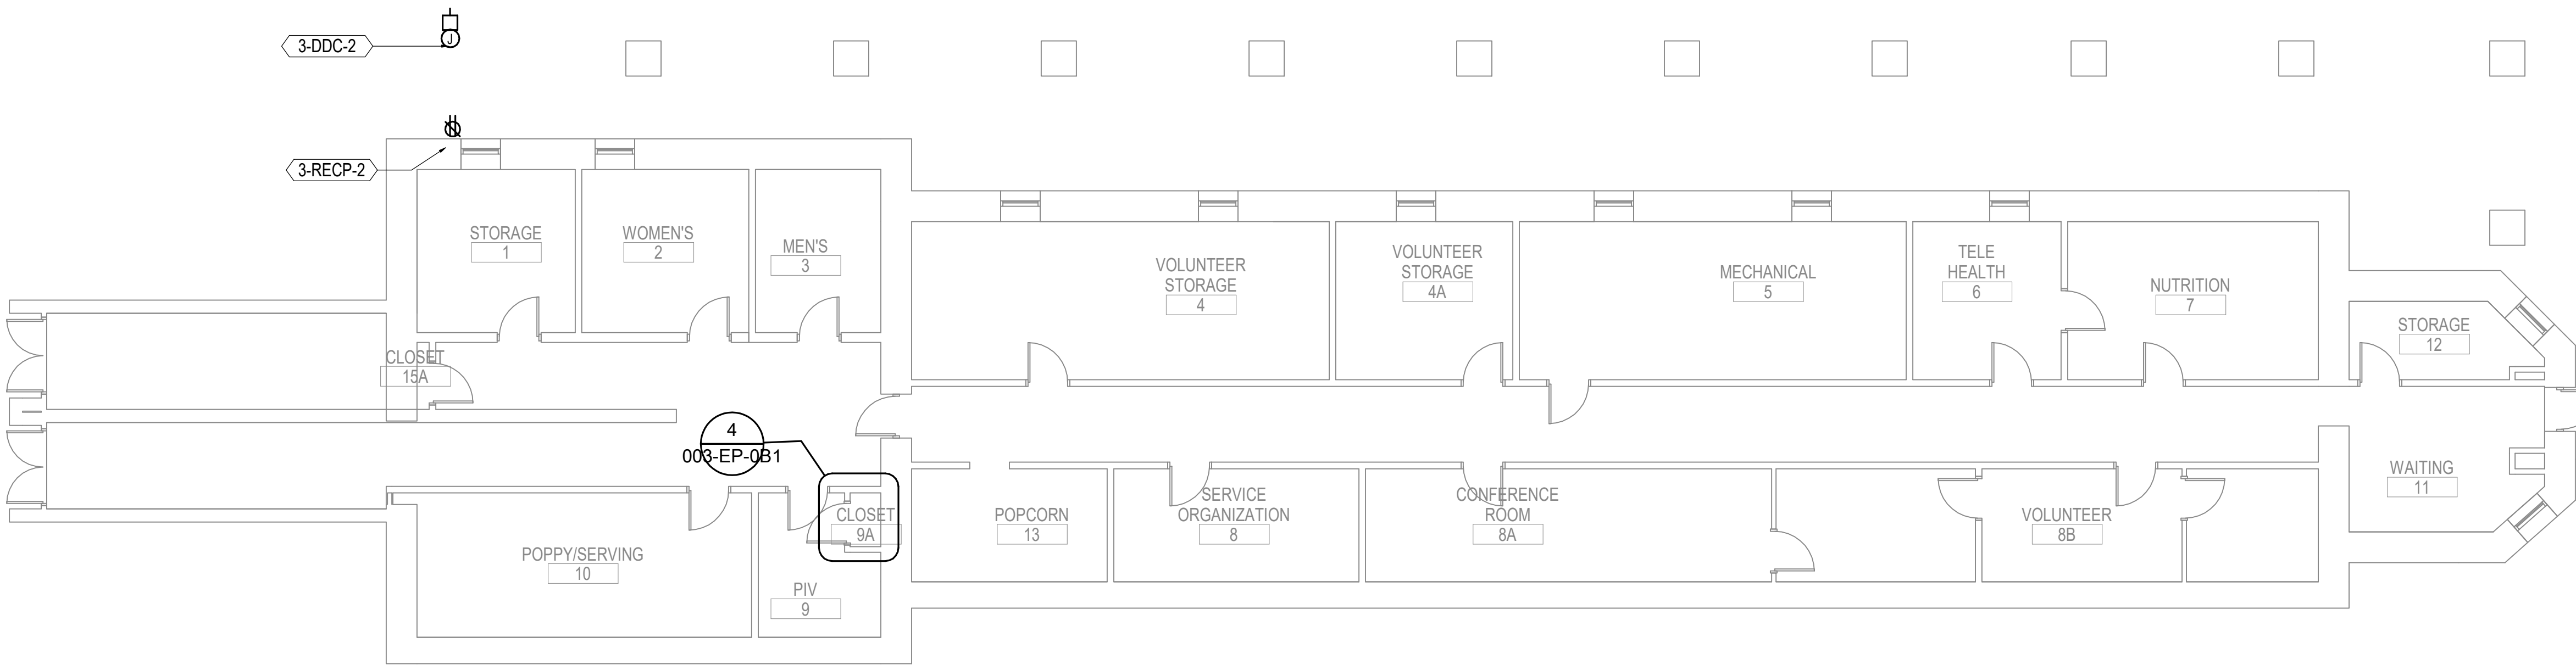

4 ENLARGED ROOM - B9A ELECTRICAL REMODEL
1/2" = 1'-0"

SITE LEGEND

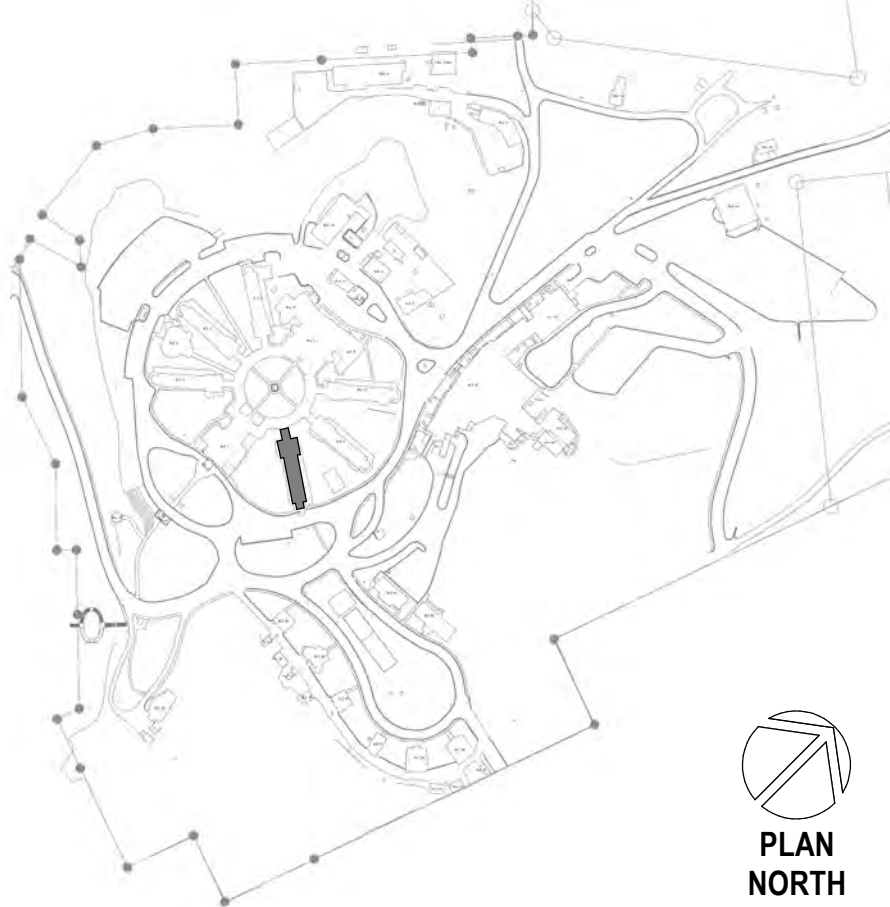

Revisions:	Date:

CONSULTANT

A/E:
GDM
1000 W STEUBEN ST. UNIT 3
BINGEN, WA 98605
541.436.4723
ADAM GOODIN, PE

GDM
ARCHITECTS • ENGINEERS

ARCHITECT/ENGINEER OF RECORD

RSA
Engineering, Inc.
MECHANICAL AND ELECTRICAL CONSULTING ENGINEERS
670 West Fireweed Lane, Suite 200
Anchorage, AK 99503
Phone (907) 278-0521
Corporate No.: AEC0542

STAMP

STATE OF ALASKA
JEREMY A. MAXIE
EE-115847
REGISTERED PROFESSIONAL ENGINEER

PROGRAM CONTRACTING ACTIVITY CENTRAL (PCAC)

VA U.S. Department of Veterans Affairs

DRAWING TITLE
ELECTRICAL REMODEL PLAN - BLDG 3

APPROVED: Project Director

PHASE
100% CD FINAL SOLUTION

FLS
FULLY SPRINKLERED

PROJECT TITLE
EHRM INFRASTRUCTURE UPGRADES

LOCATION
HOT SPRINGS, SOUTH DAKOTA

ISSUE DATE
2/22/2022

CHECKED BY
JAM

DRAWN BY
CSZ

PROJECT NUMBER
568A4-21-702

BUILDING NUMBER
03

DRAWING NUMBER
003-EP-081

A

B


C

D

E

F


2/22/2022 8:06:01 PM
C:\Users\Caleb\AppData\Local\Temp\REVIT 2020 LOCAL\SM1121 ESERIES BLDG 4\201_4.supp\OGETM.rvt

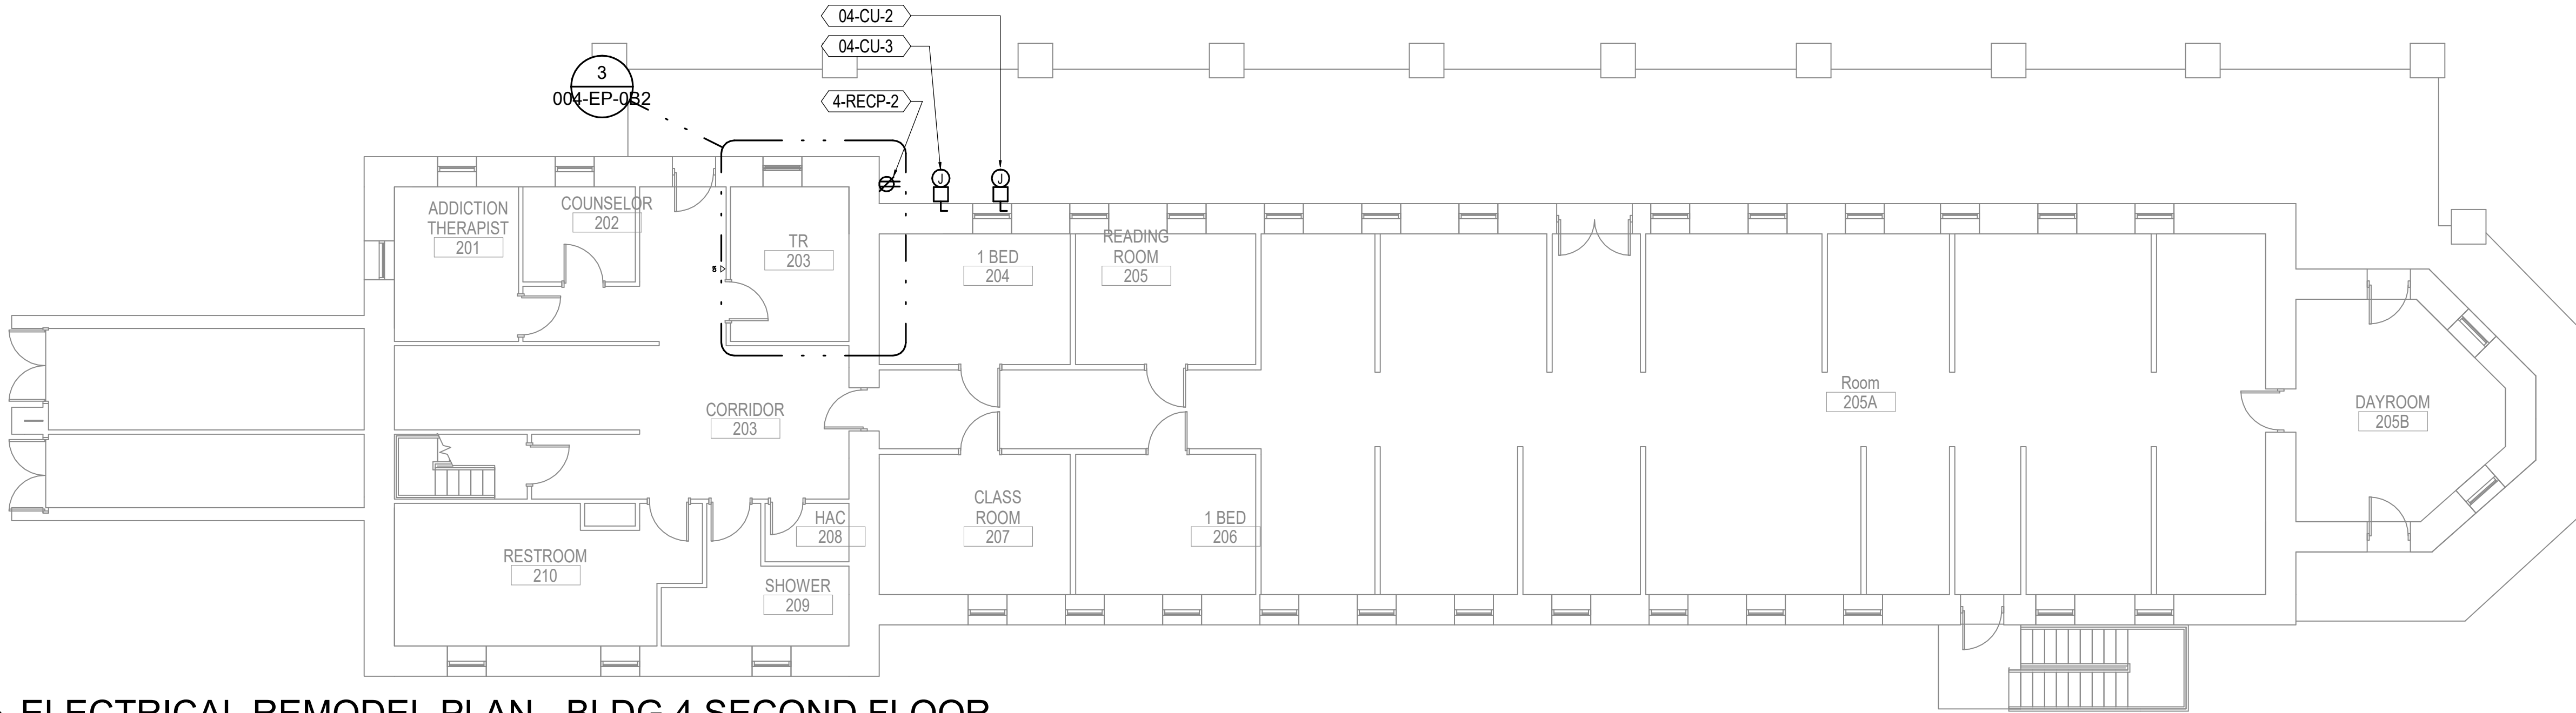


GENERAL NOTES:

- A. SEE EQUIPMENT SCHEDULE ON SHEET 004-EP-021 FOR POWER REQUIREMENTS.
- B. COORDINATE WITH MECHANICAL DRAWINGS FOR EQUIPMENT LOCATIONS AND CONDUIT/PIPE ROUTING PRIOR TO ROUGH-IN.

3 ELECTRICAL REMODEL PLAN - BLDG 4 SECOND FLOOR
1/8" = 1'-0"

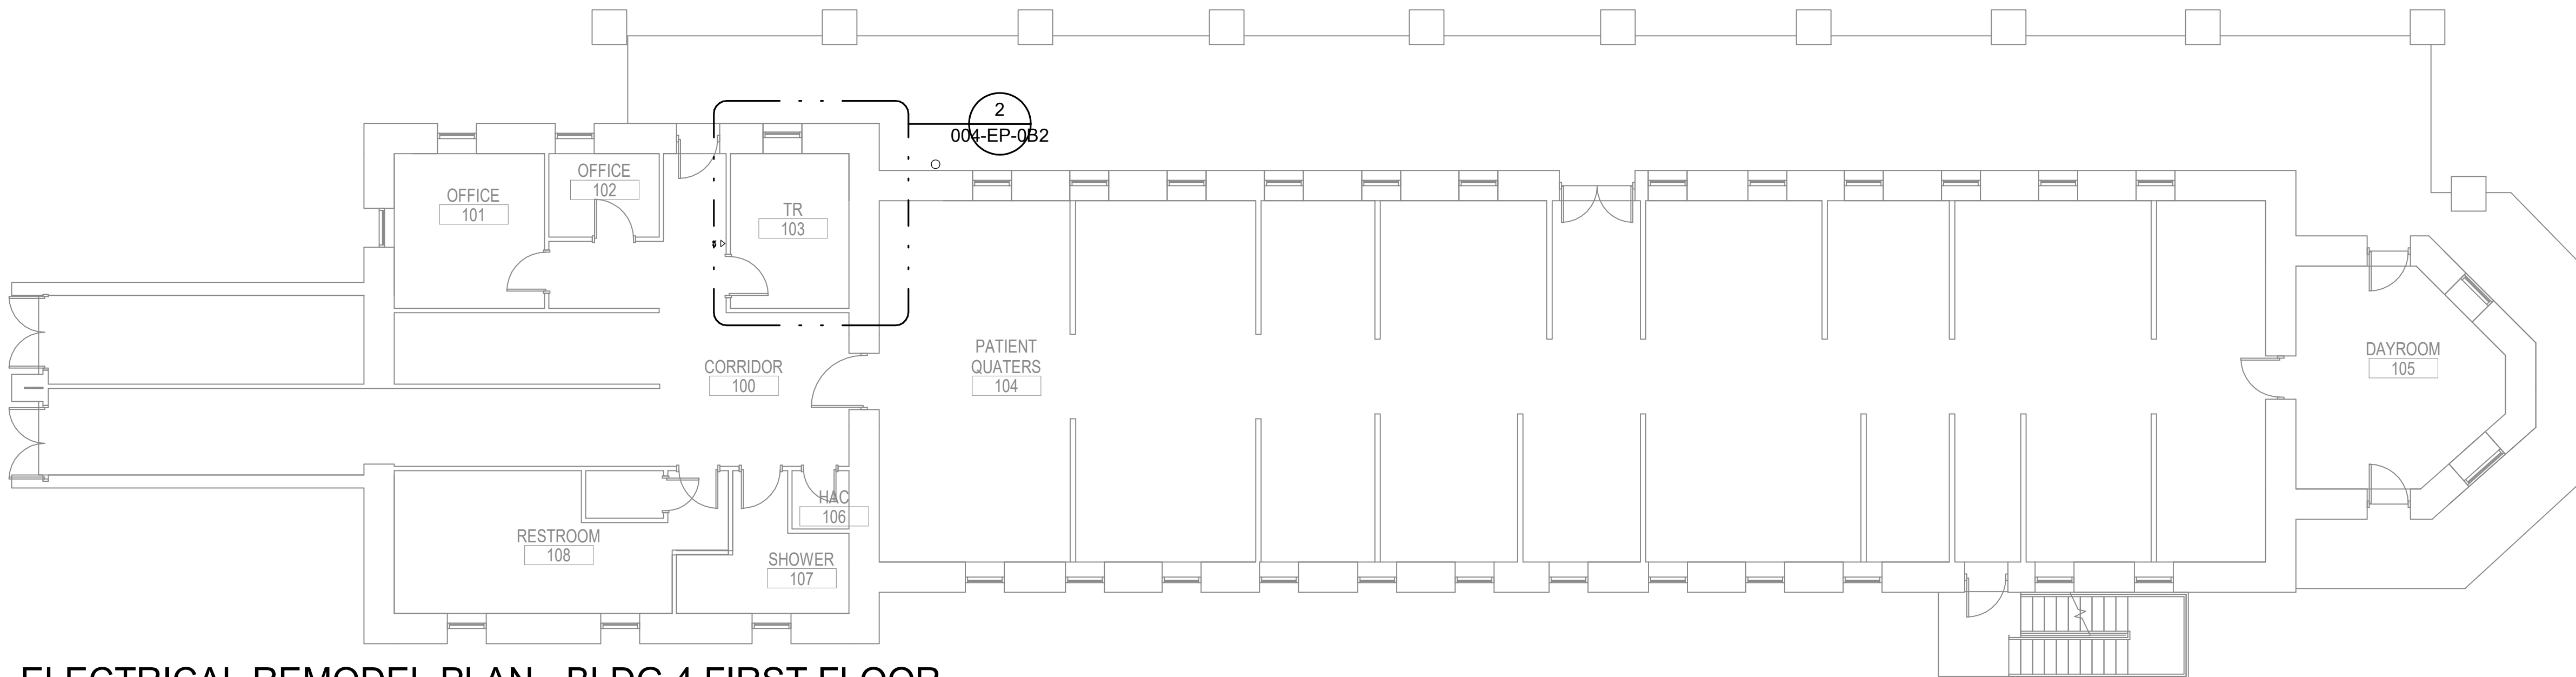


2 ELECTRICAL REMODEL PLAN - BLDG 4 FIRST FLOOR
1/8" = 1'-0"

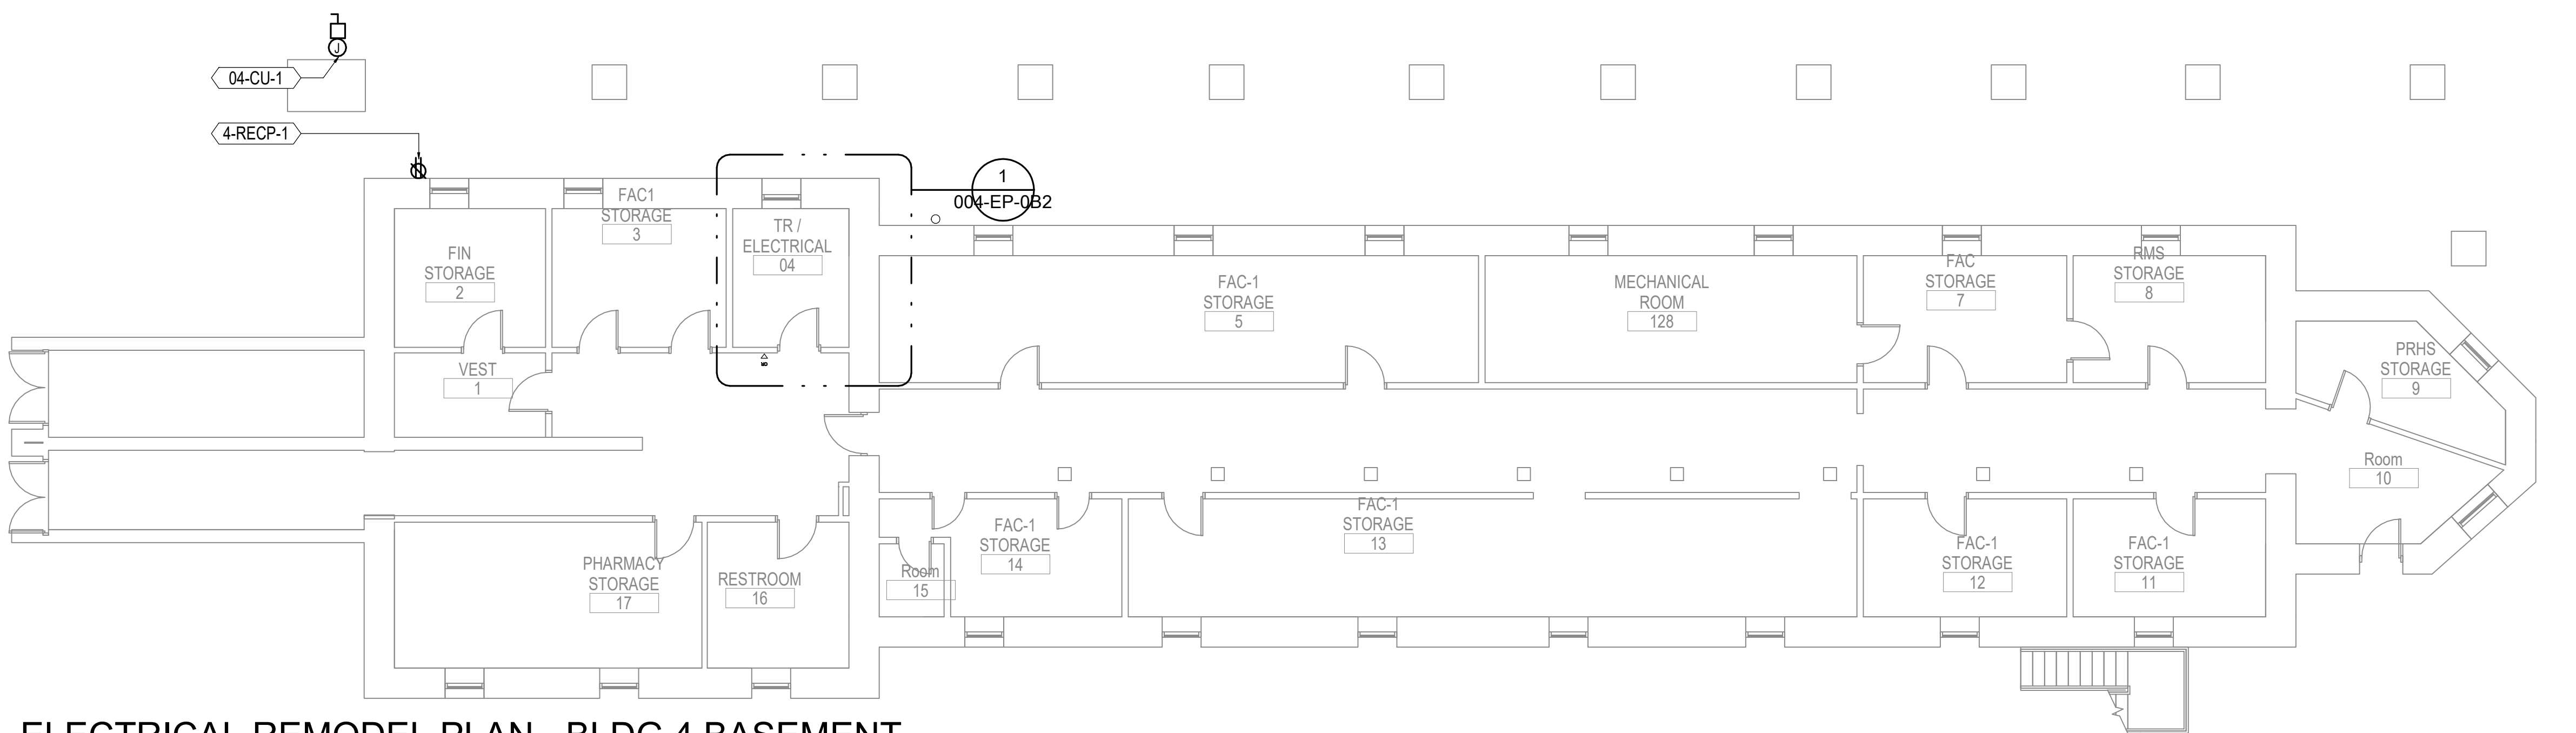

1 ELECTRICAL REMODEL PLAN - BLDG 4 BASEMENT
1/8" = 1'-0"



SITE LEGEND

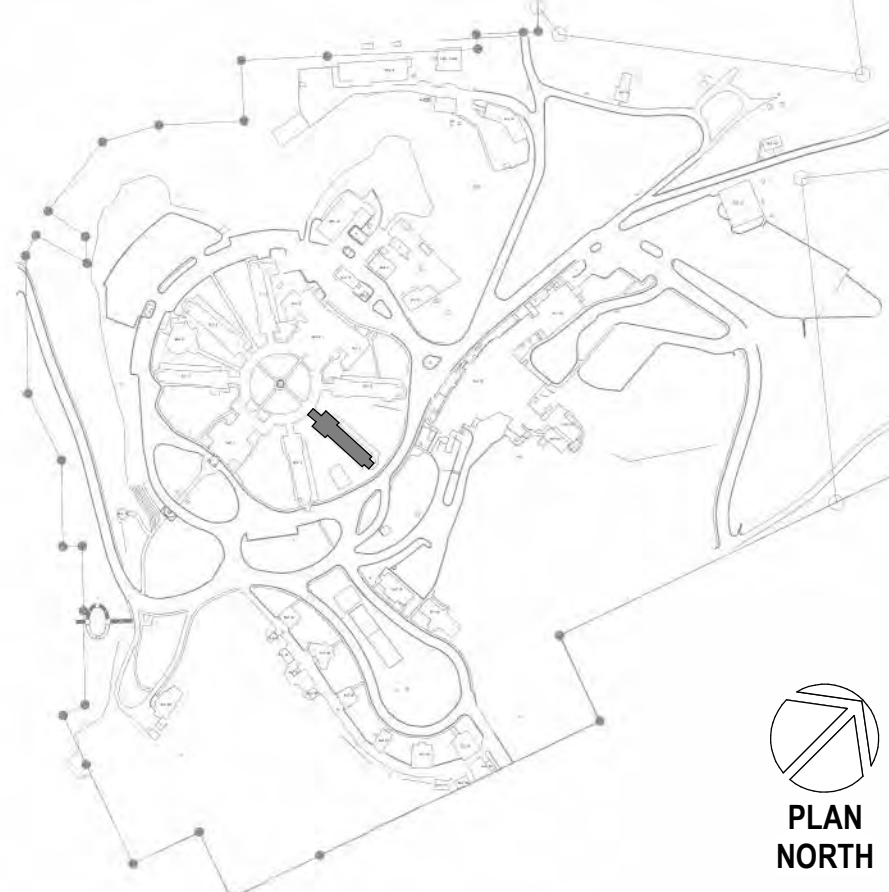

Revisions:	Date:

CONSULTANT

A/E:
GDM
1000 W STEUBEN ST. UNIT 3
BINGEN, WA 98605
541.436.4723
ADAM GOODIN, PE

GDM
ARCHITECTS • ENGINEERS

ARCHITECT/ENGINEER OF RECORD

RSA
Engineering, Inc.
MECHANICAL AND ELECTRICAL CONSULTING ENGINEERS
670 West Fireweed Lane, Suite 200
Anchorage, AK 99503
Phone (907) 278-0521
Corporate No.: AEC0542

STAMP

STATE OF ALASKA
JEREMY A. MAXIE
EE-13947
REGISTERED PROFESSIONAL ENGINEER

PROGRAM CONTRACTING ACTIVITY CENTRAL (PCAC)

VA U.S. Department of Veterans Affairs

DRAWING TITLE
ELECTRICAL REMODEL PLAN - BLDG 4 LAYOUTS

APPROVED: Project Director

PHASE
100% CD FINAL SOLUTION

FLS
FULLY SPRINKLERED

PROJECT TITLE
EHRM INFRASTRUCTURE UPGRADES

LOCATION
HOT SPRINGS, SOUTH DAKOTA

ISSUE DATE
2/22/2022

CHECKED BY
JAM

DRAWN BY
NVF

PROJECT NUMBER
568A4-21-702

BUILDING NUMBER
04

DRAWING NUMBER
004-EP-0B1

A

B

C

D

E


F

2/22/2022 8:08:02 PM


C:\Users\Caleb\AppData\Local\Microsoft\OneDrive\OneDrive\Documents\REVIT 2020 LOCAL\SM1121 - ESRIES - BLDG 4.rvt

1


3 ENLARGED ROOM - 203 ELECTRICAL REMODEL
1/2" = 1'-0"

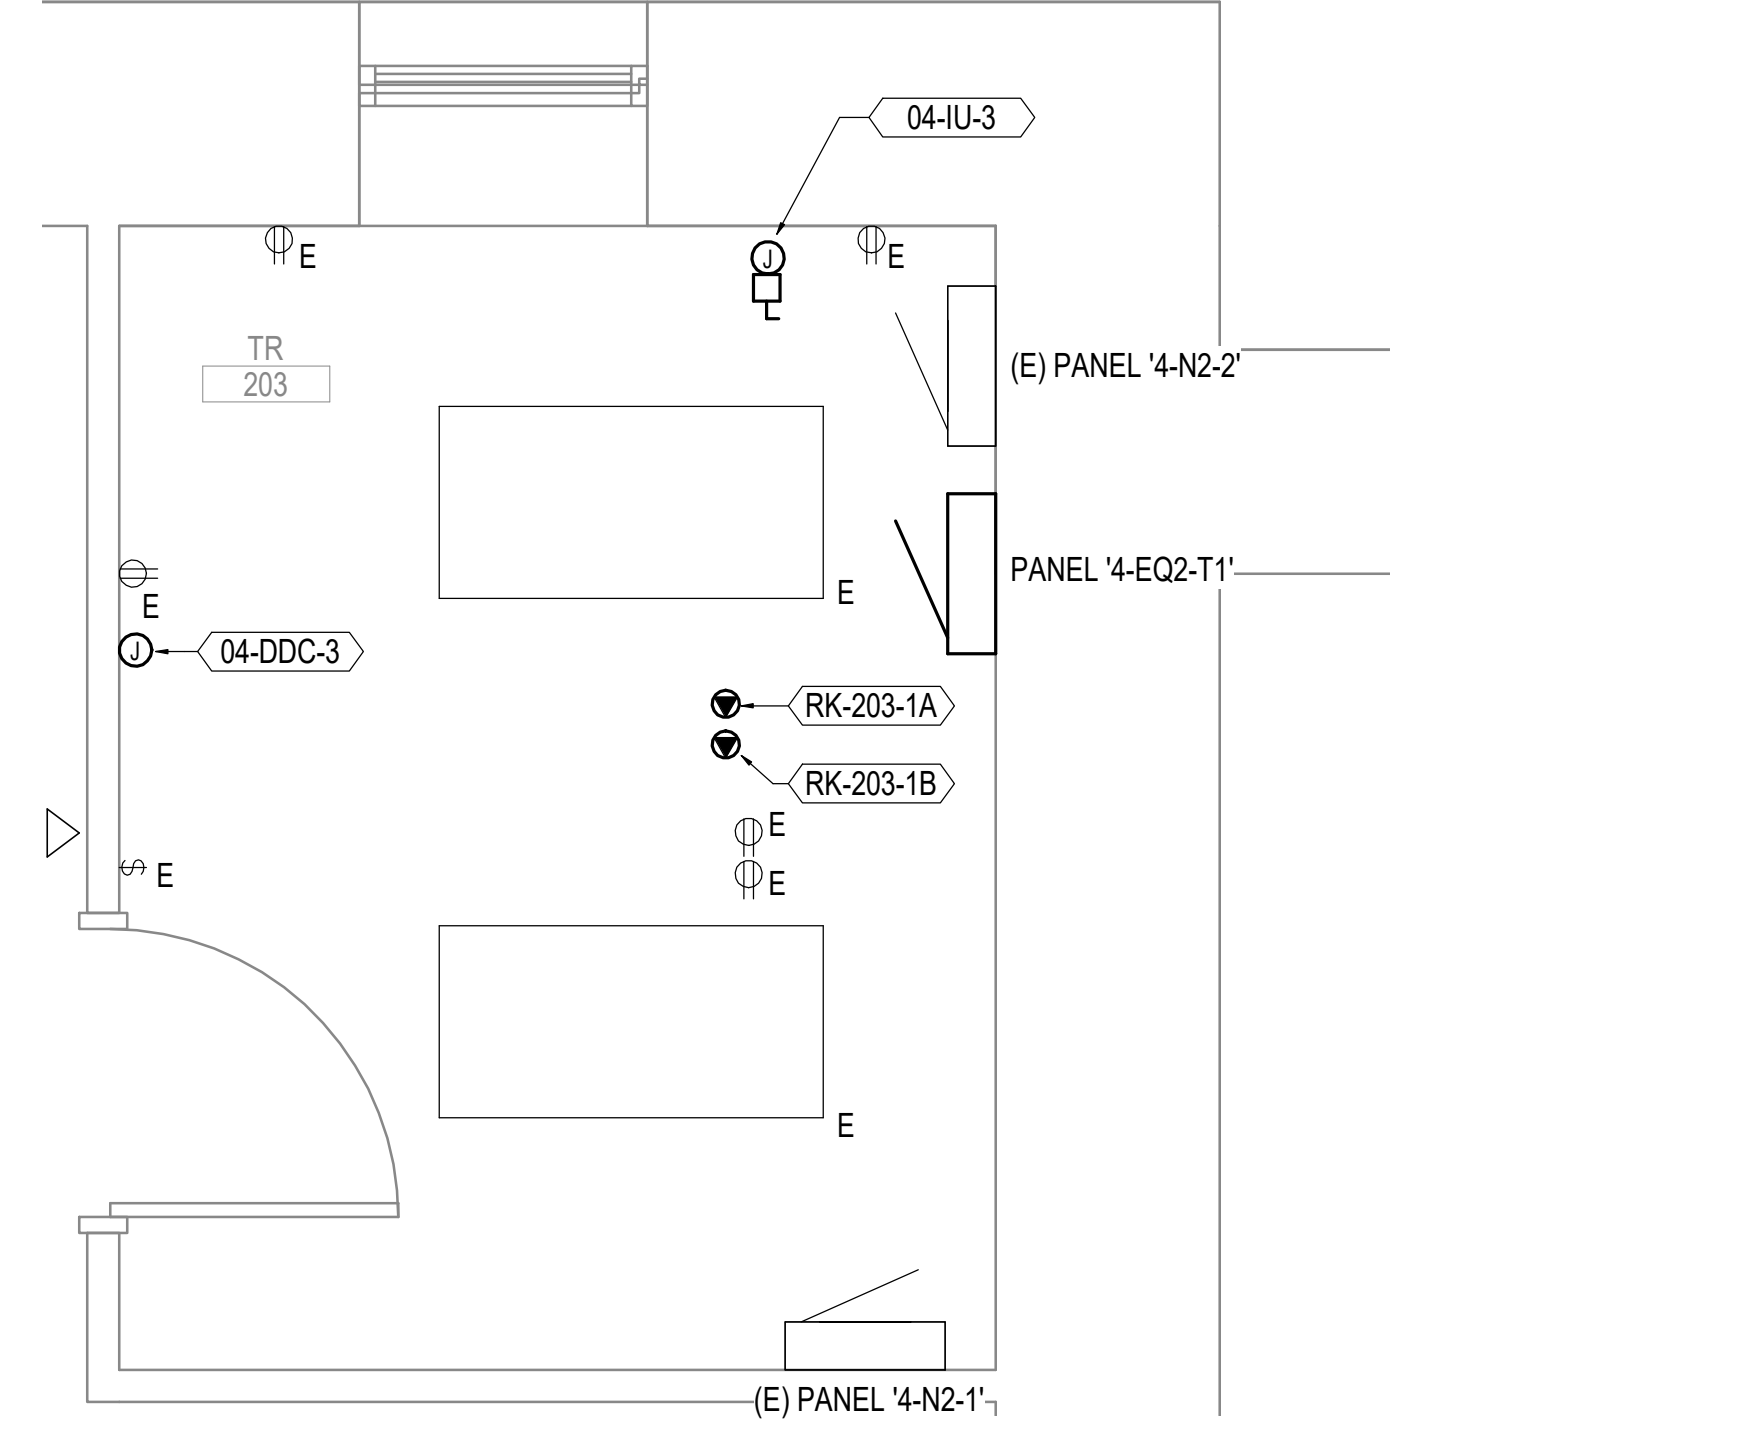

1 ENLARGED ROOM - 04 ELECTRICAL REMODEL
1/2" = 1'-0"

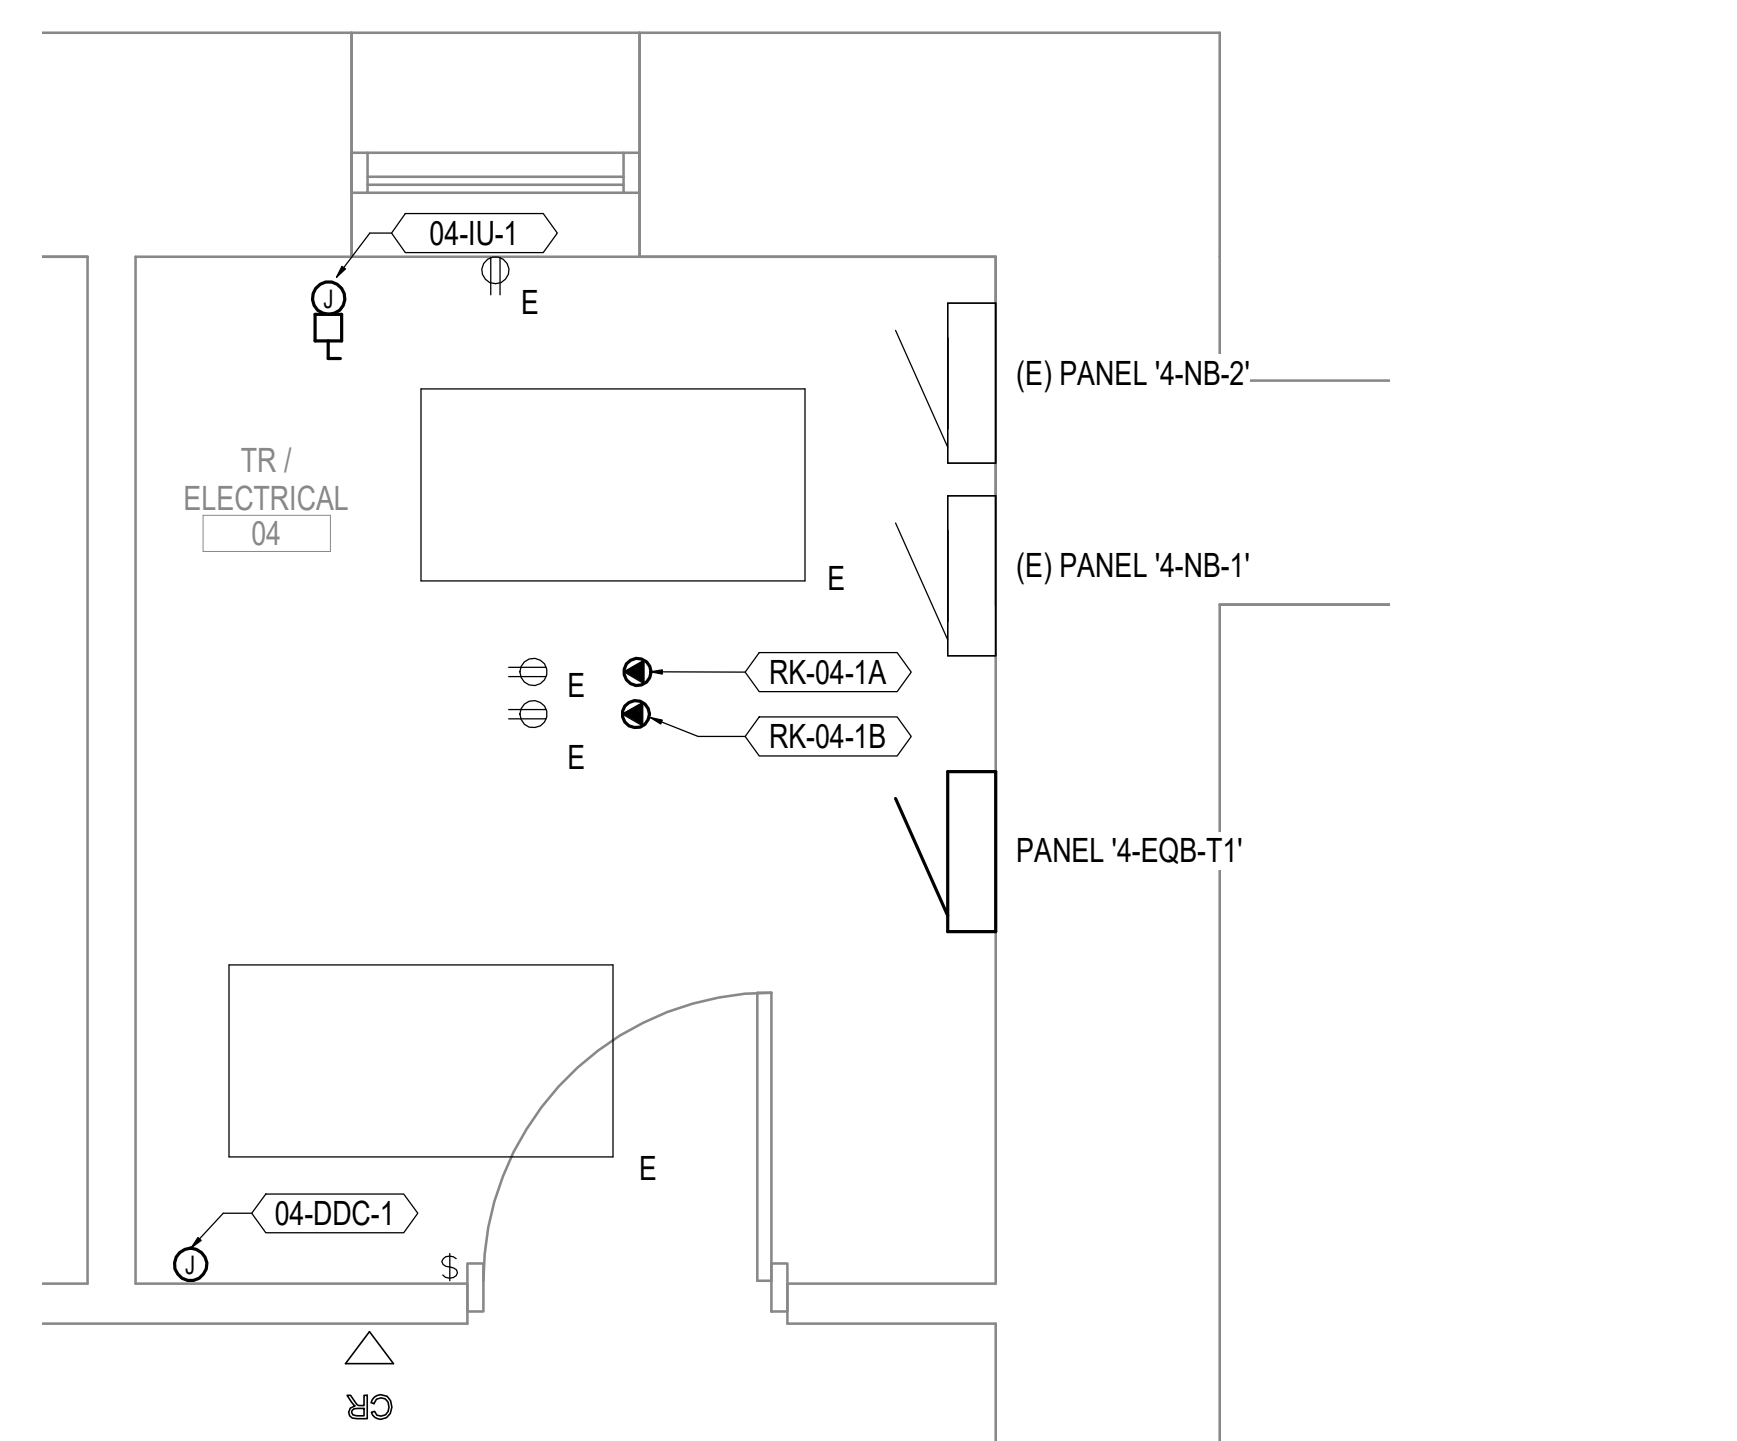

2 ENLARGED ROOM - 103 ELECTRICAL REMODEL
1/2" = 1'-0"

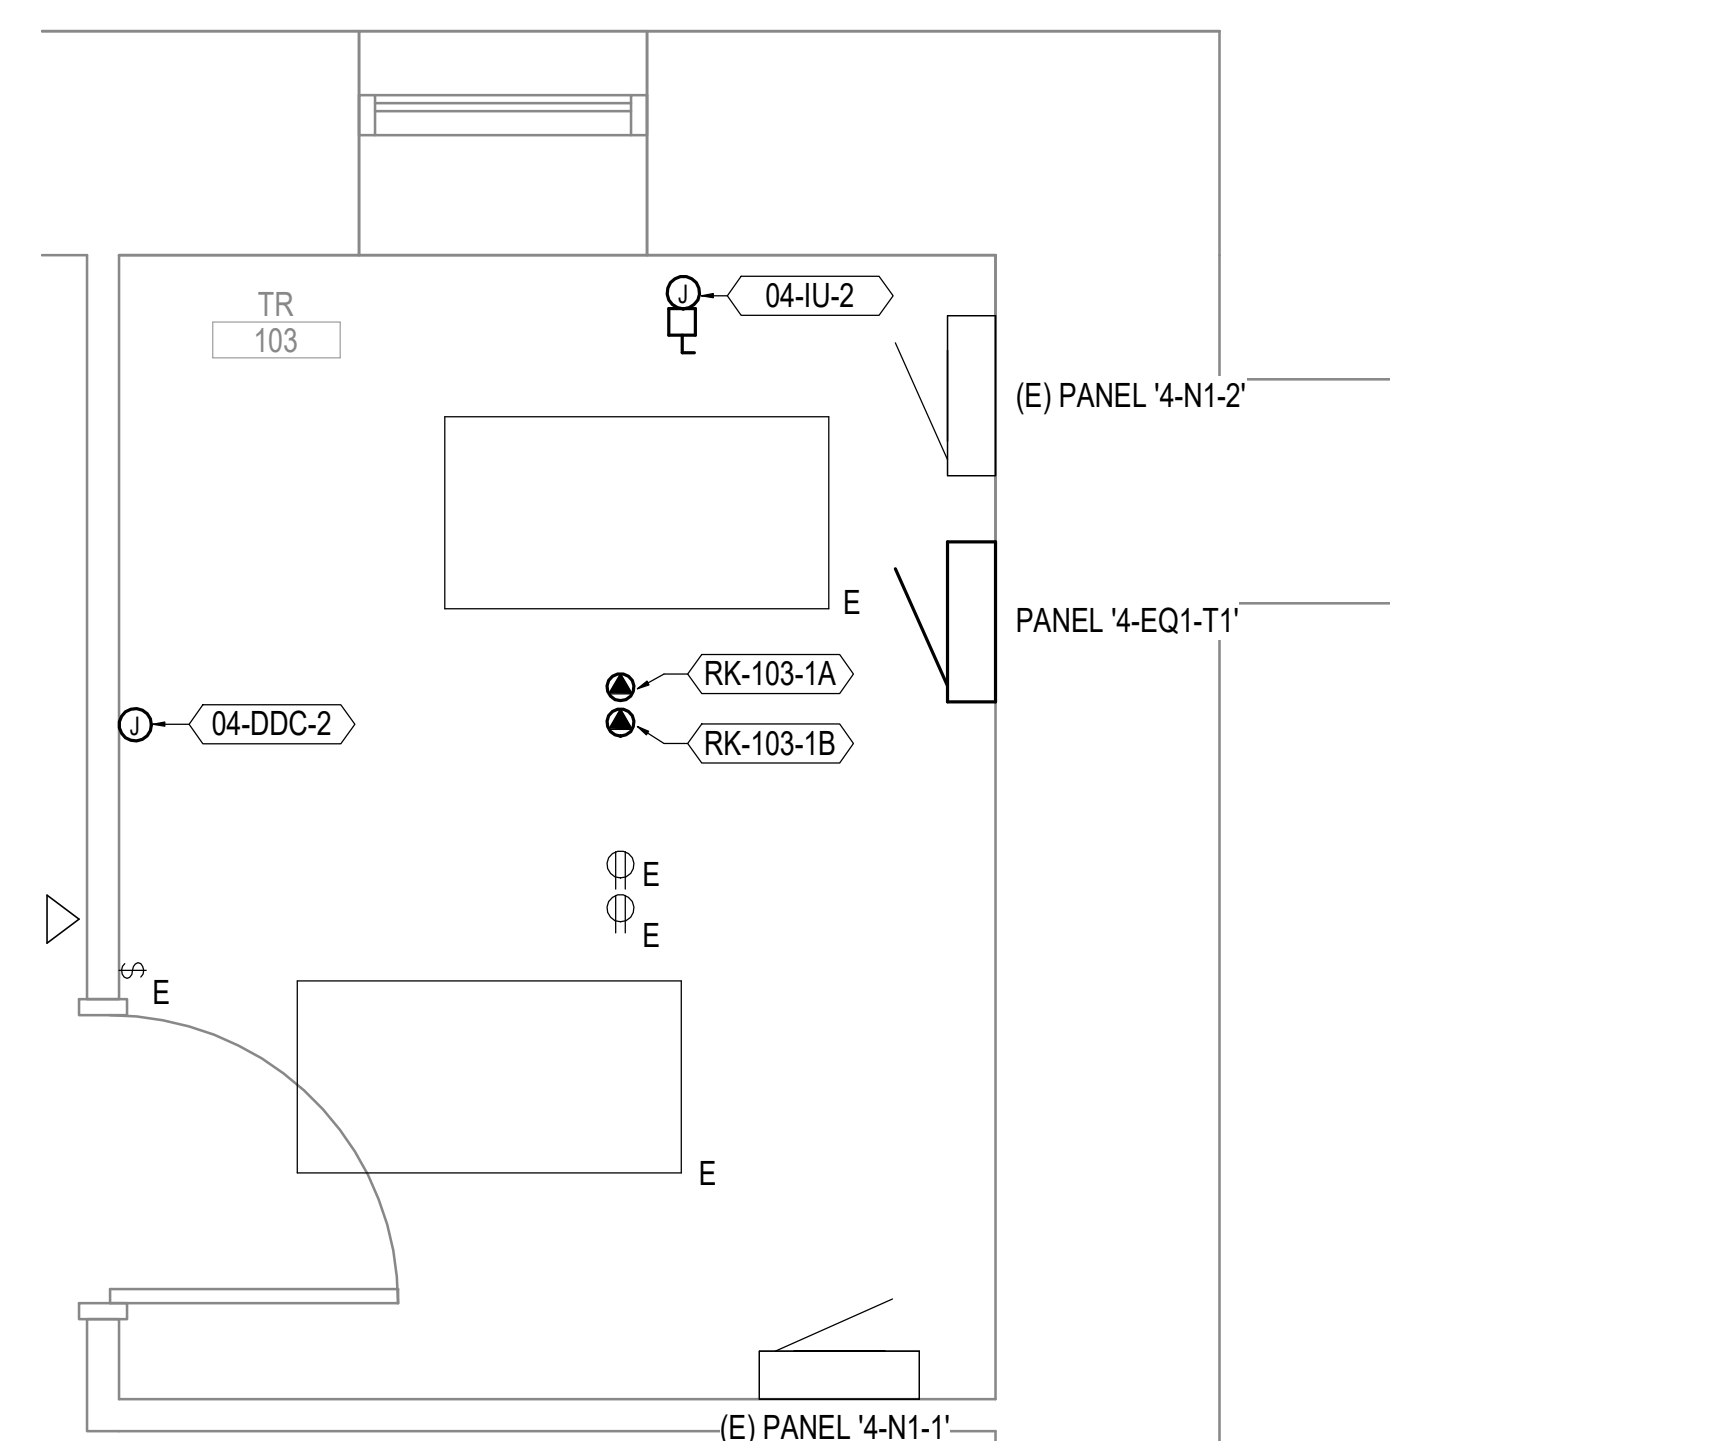


EQUIPMENT SCHEDULE - BUILDING 4

ID TAG	EQUIPMENT DESCRIPTION	ELECTRICAL DATA						REQUIRES DISCONNECT	PANEL / CIRCUIT	CONDUIT / CONDUCTOR SIZE	NOTES
		HP	AMP	WATT	VA	VOLT	Φ				
4-IU-1	AC INDOOR UNIT	-	30	-	-	208	1	X	4-NB-1-18,20	0.75" C, 2#8, 1#10 GND	INTEGRAL CONTROLLER
4-IU-2	AC INDOOR UNIT	-	30	-	-	208	1	X	4-N1-1-23,25	0.75" C, 2#8, 1#10 GND	INTEGRAL CONTROLLER
4-IU-3	AC INDOOR UNIT	-	30	-	-	208	1	X	4-N2-1-25,27	0.75" C, 2#8, 1#10 GND	INTEGRAL CONTROLLER
4-CU-1	CONDENSING UNIT	-	20.5	-	-	208	1	X	4-NB-1-14,16	0.75" C, 2#10, 1#10 GND	INTEGRAL CONTROLLER
4-CU-2	CONDENSING UNIT	-	20.5	-	-	208	1	X	4-N1-1-19,21	0.75" C, 2#10, 1#10 GND	INTEGRAL CONTROLLER
4-CU-3	CONDENSING UNIT	-	20.5	-	-	208	1	X	4-N2-1-26,28	0.75" C, 2#10, 1#10 GND	INTEGRAL CONTROLLER
4-DDC-1	DDC FOR INDOOR UNIT	-	-	50	-	120	1	N/A	4-EQ8-T1-4	0.75" C, 1#12, 1#12 NEUT, 1#12 GND	COORDINATE WITH MECH FOR LOCATION
4-DDC-2	DDC FOR INDOOR UNIT	-	-	50	-	120	1	N/A	4-EQ1-T1-4	0.75" C, 1#12, 1#12 NEUT, 1#12 GND	COORDINATE WITH MECH FOR LOCATION
4-DDC-3	DDC FOR INDOOR UNIT	-	-	50	-	120	1	N/A	4-EQ2-T1-4	0.75" C, 1#12, 1#12 NEUT, 1#12 GND	COORDINATE WITH MECH FOR LOCATION
RK-04-1A	TELECOM RACK RECEPTACLE	-	-	5000	-	208	3	N/A	4-EQ8-T1-1,3,5	0.75" C, 3#12, 1#10 NEUT, 1#12 GND	PROVIDE NEMA 121-20R, SEE 5/000-I-001
RK-04-1B	TELECOM RACK RECEPTACLE	-	-	5000	-	208	3	N/A	4-NB-1-8,10,12	0.75" C, 3#12, 1#10 NEUT, 1#12 GND	PROVIDE NEMA 121-20R, SEE 5/000-I-001
RK-103-1A	TELECOM RACK RECEPTACLE	-	-	5000	-	208	3	N/A	4-EQ1-T1-1,3,5	0.75" C, 3#12, 1#10 NEUT, 1#12 GND	PROVIDE NEMA 121-20R, SEE 5/000-I-001
RK-103-1B	TELECOM RACK RECEPTACLE	-	-	5000	-	208	3	N/A	4-N1-2-9,11,13	0.75" C, 3#12, 1#10 NEUT, 1#12 GND	PROVIDE NEMA 121-20R, SEE 5/000-I-001
RK-203-1A	TELECOM RACK RECEPTACLE	-	-	5000	-	208	3	N/A	4-EQ2-T1-1,3,5	0.75" C, 3#12, 1#10 NEUT, 1#12 GND	PROVIDE NEMA 121-20R, SEE 5/000-I-001
RK-203-1B	TELECOM RACK RECEPTACLE	-	-	5000	-	208	3	N/A	4-N2-2-12,14,16	0.75" C, 3#12, 1#10 NEUT, 1#12 GND	PROVIDE NEMA 121-20R, SEE 5/000-I-001
4-REC-1	CONVENIENCE RECEPTACLE	-	-	-	180	120	1	N/A	4-NB-1-22	0.75" C, 2#12, 1#12 GND	PROVIDE GFCI, WEATHERPROOF CONVENIENCE RECEPTACLE
4-REC-2	CONVENIENCE RECEPTACLE	-	-	-	180	120	1	N/A	4-N2-1-1	0.75" C, 2#12, 1#12 GND	PROVIDE GFCI, WEATHERPROOF CONVENIENCE RECEPTACLE

GENERAL NOTES:

- A. SEE EQUIPMENT SCHEDULE ON THIS SHEET FOR POWER REQUIREMENTS.
- B. COORDINATE WITH MECHANICAL DRAWINGS FOR EQUIPMENT LOCATIONS AND CONDUIT/PIPE ROUTING PRIOR TO ROUGH-IN.
- C. PROVIDE RELOCATION OF EXISTING LED LIGHTING ONLY AS REQUIRED TO ACCOMMODATE NEW EQUIPMENT.

SITE LEGEND

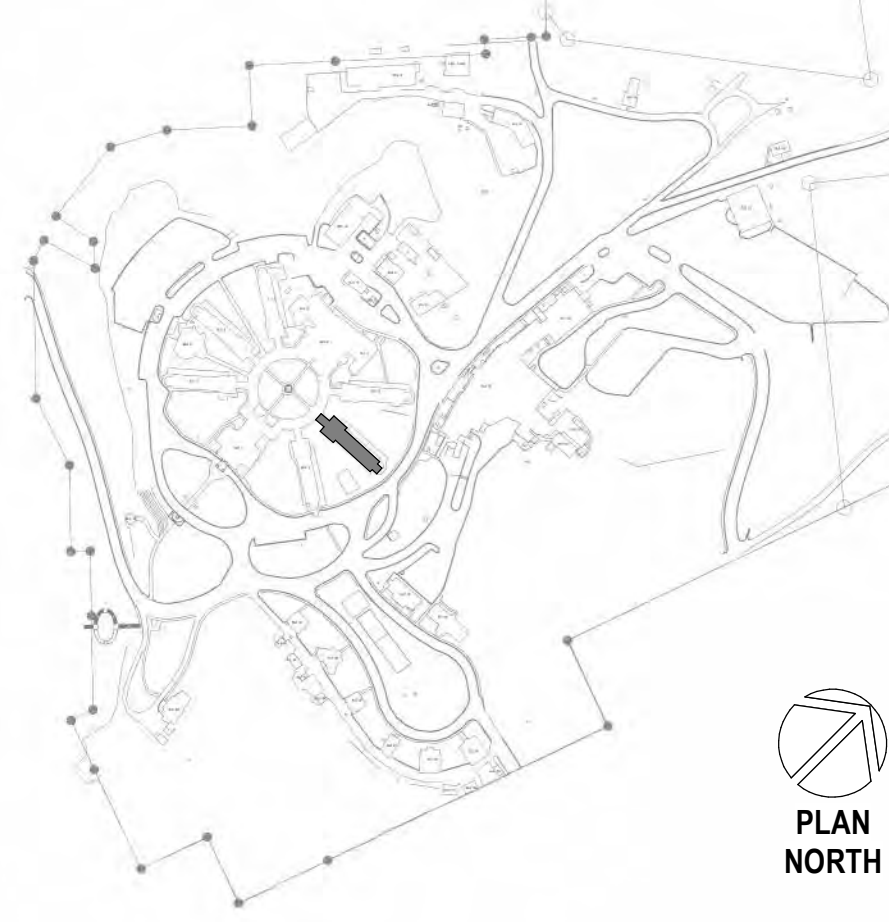

CONSULTANT

A/E:
GDM
1000 W STEUBEN ST. UNIT 3
BINGEN, WA 98605
541.436.4723
ADAM GOODIN, PE

GDM
ARCHITECTS • ENGINEERS

ARCHITECT/ENGINEER OF RECORD

RSA
Engineering, Inc.
MECHANICAL AND ELECTRICAL CONSULTING ENGINEERS
670 West Firwood Lane, Suite 200
Anchorage, AK 99503
Phone (907) 276-0521
Corporate No.: AEC0542

STAMP

STATE OF ALASKA
JEREMY A. MAXIE
REGISTERED PROFESSIONAL ENGINEER
No. 13847

PROGRAM CONTRACTING ACTIVITY CENTRAL (PCAC)

VA U.S. Department of Veterans Affairs

DRAWING TITLE

ELECTRICAL REMODEL PLAN - BLDG 4 ENLARGED PLANS

APPROVED: Project Director

PHASE

100% CD FINAL SOLUTION

FLS

FULLY SPRINKLERED

PROJECT TITLE

EHRM INFRASTRUCTURE UPGRADES

LOCATION

HOT SPRINGS, SOUTH DAKOTA

ISSUE DATE

2/22/2022

CHECKED BY

JAM

DRAWN BY

NVF

PROJECT NUMBER

568A4-21-702

BUILDING NUMBER

04

DRAWING NUMBER


004-EP-0B2

EQUIPMENT SCHEDULE - BUILDING 5


- A. SEE EQUIPMENT SCHEDULE ON THIS SHEET FOR POWER REQUIREMENTS
- B. COORDINATE LIGHTING LAYOUT WITH RACK AND CABLE TRAY LOCATIONS TO PROVIDE ILLUMINATION ON EQUIPMENT PER LIGHTING DESIGN REQUIREMENTS.
- C. COORDINATE WITH MECHANICAL DRAWINGS FOR EQUIPMENT LOCATIONS AND CONDUIT/PIPE ROUTING PRIOR TO ROUGH-IN.

1. PROVIDE RACEWAY AND BOXES FOR ACCESS CONTROLS SYSTEM COMPONENTS. SEE EK-104 FOR TYPICAL DOOR DETAIL.


ID TAG	EQUIPMENT DESCRIPTION	ELECTRICAL DATA						REQUIRES DISCONNECT	PANEL / CIRCUIT	CONDUIT / CONDUCTOR SIZE	NOTES
		HP	AMP	WATT	VA	VOLT	Ø				
5-IU-1	AC INDOOR UNIT	-	34.2	-	-	208	1	X	5-N2-T1-7.9	0.75" 2#6, 1#10 GND	INTEGRAL CONTROLLER
5-CU-1	CONDENSING UNIT	-	20.8	-	-	208	1	X	5-N2-T1-11.13	0.75" 2#10, 1#10 GND	INTEGRAL CONTROLLER
5-DDC-1	DDC FOR INDOOR UNIT	-	-	50	-	120	1	N/A	5-EQ2-T1-4	0.75" #12, 1#12 NEUT, 1#12 GND	COORDINATE WITH MECH FOR LOCATION
RK-211-1A	TELECOM RACK RECEPTACLE	-	-	5000	-	208	3	N/A	5-EQ2-T1-1,3,5	0.75" 3#12, 1#10 NEUT, 1#12 GND	PROVIDE NEMA L21-20R, SEE 5/000-1-001
RK-211-1B	TELECOM RACK RECEPTACLE	-	-	5000	-	208	3	N/A	5-N2-T1-1,3,5	0.75" 3#12, 1#10 NEUT, 1#12 GND	PROVIDE NEMA L21-20R, SEE 5/000-1-001

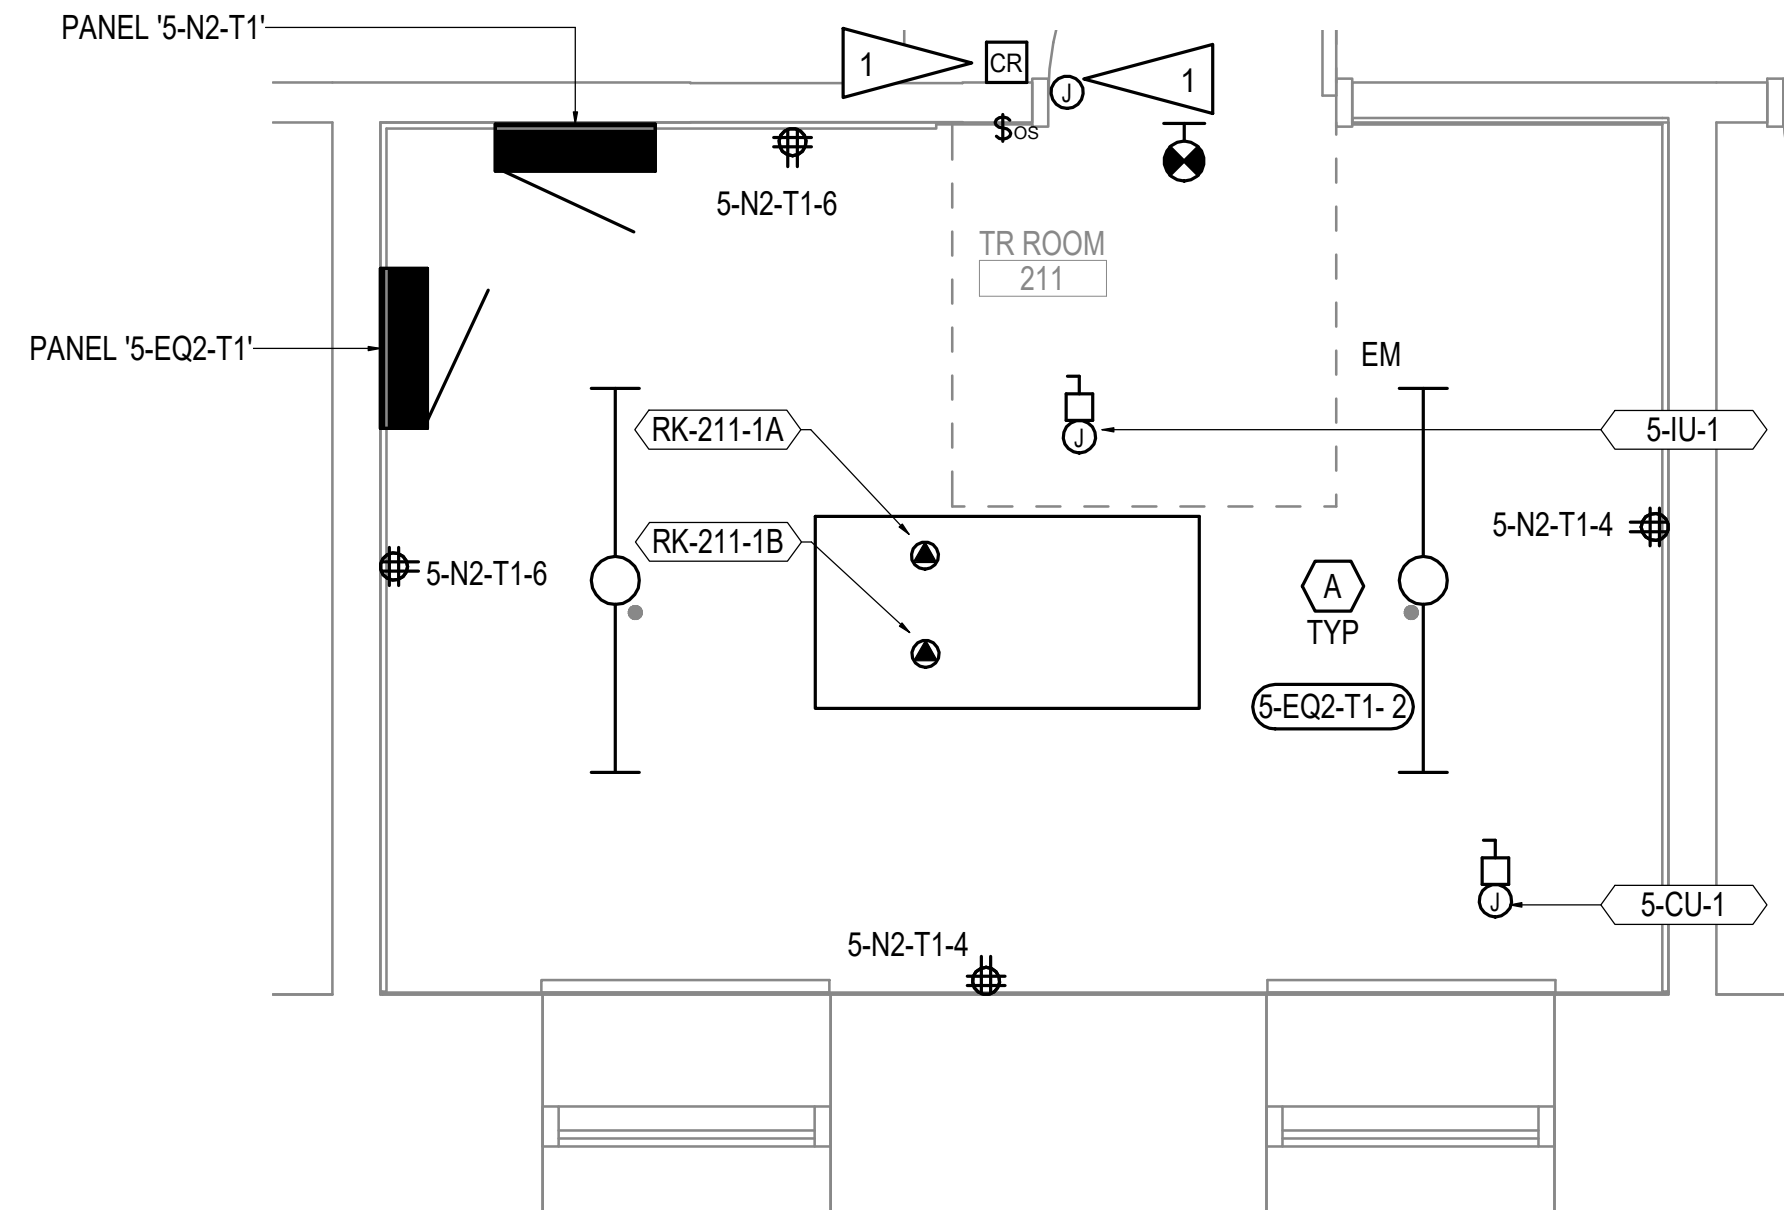


3 ENLARGED ROOM - 211 ELECTRICAL REMODEL
1/2" = 1'-0"

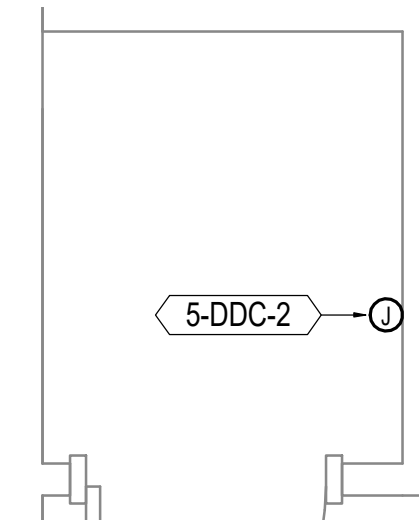

4 ENLARGED ROOM - 10B ELECTRICAL REMODEL
1/2" = 1'-0"

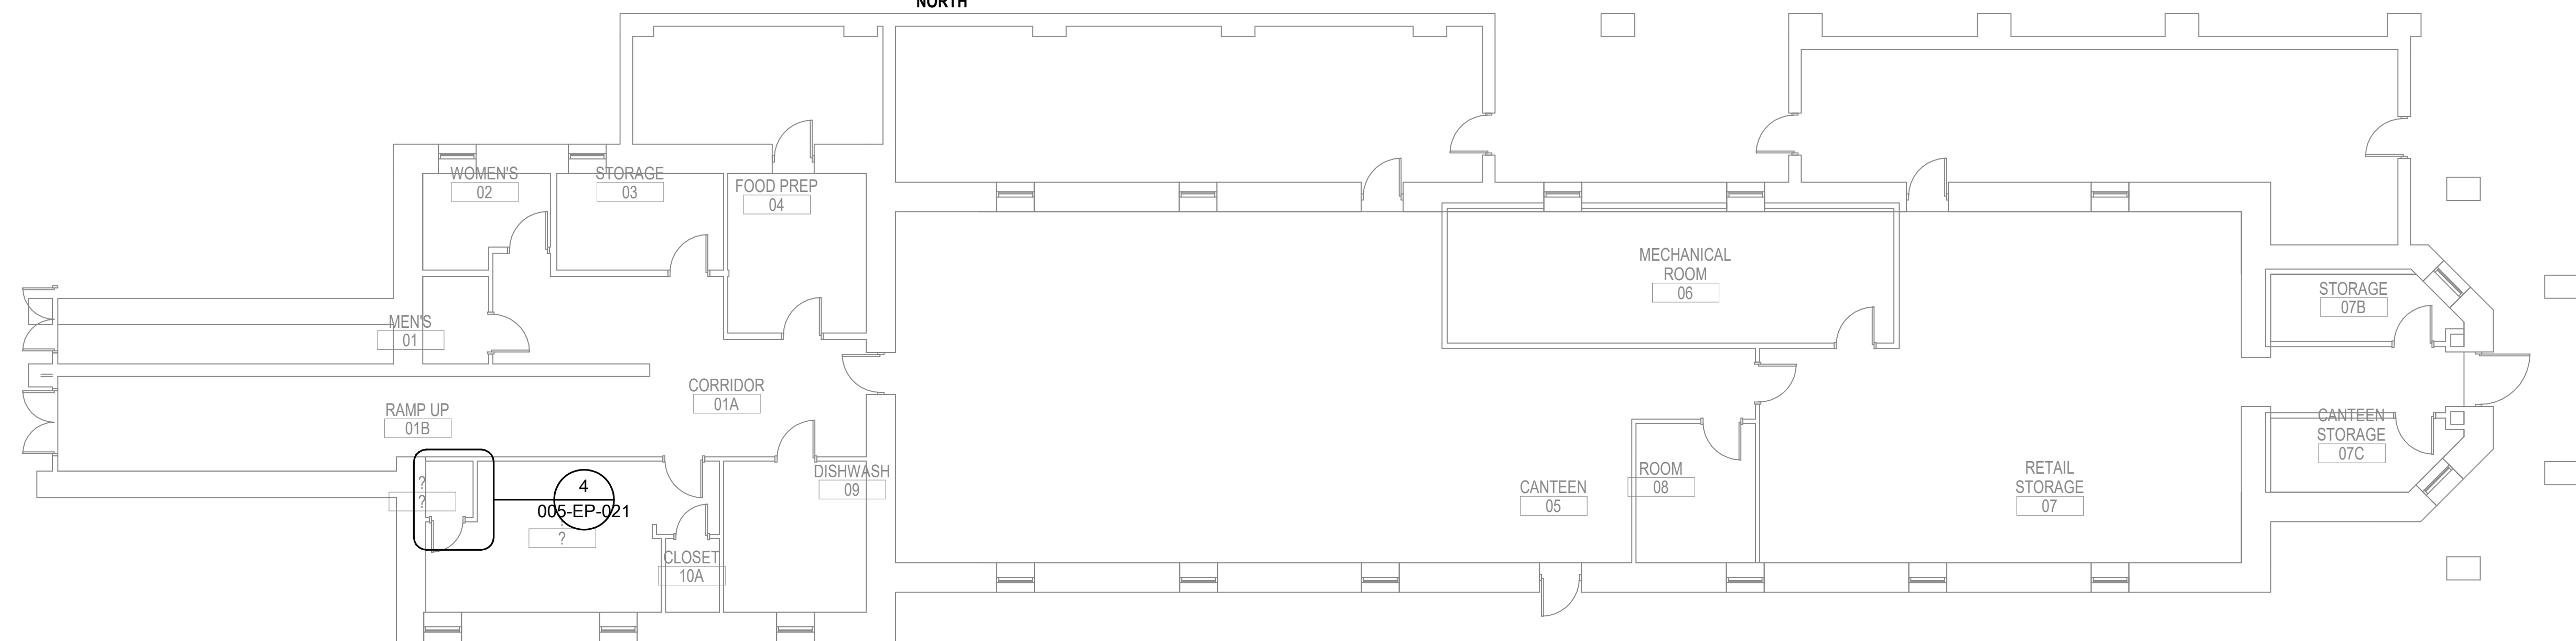


2 ELECTRICAL REMODEL PLAN - BLDG 5 BASEMENT
1/8" = 1'-0"

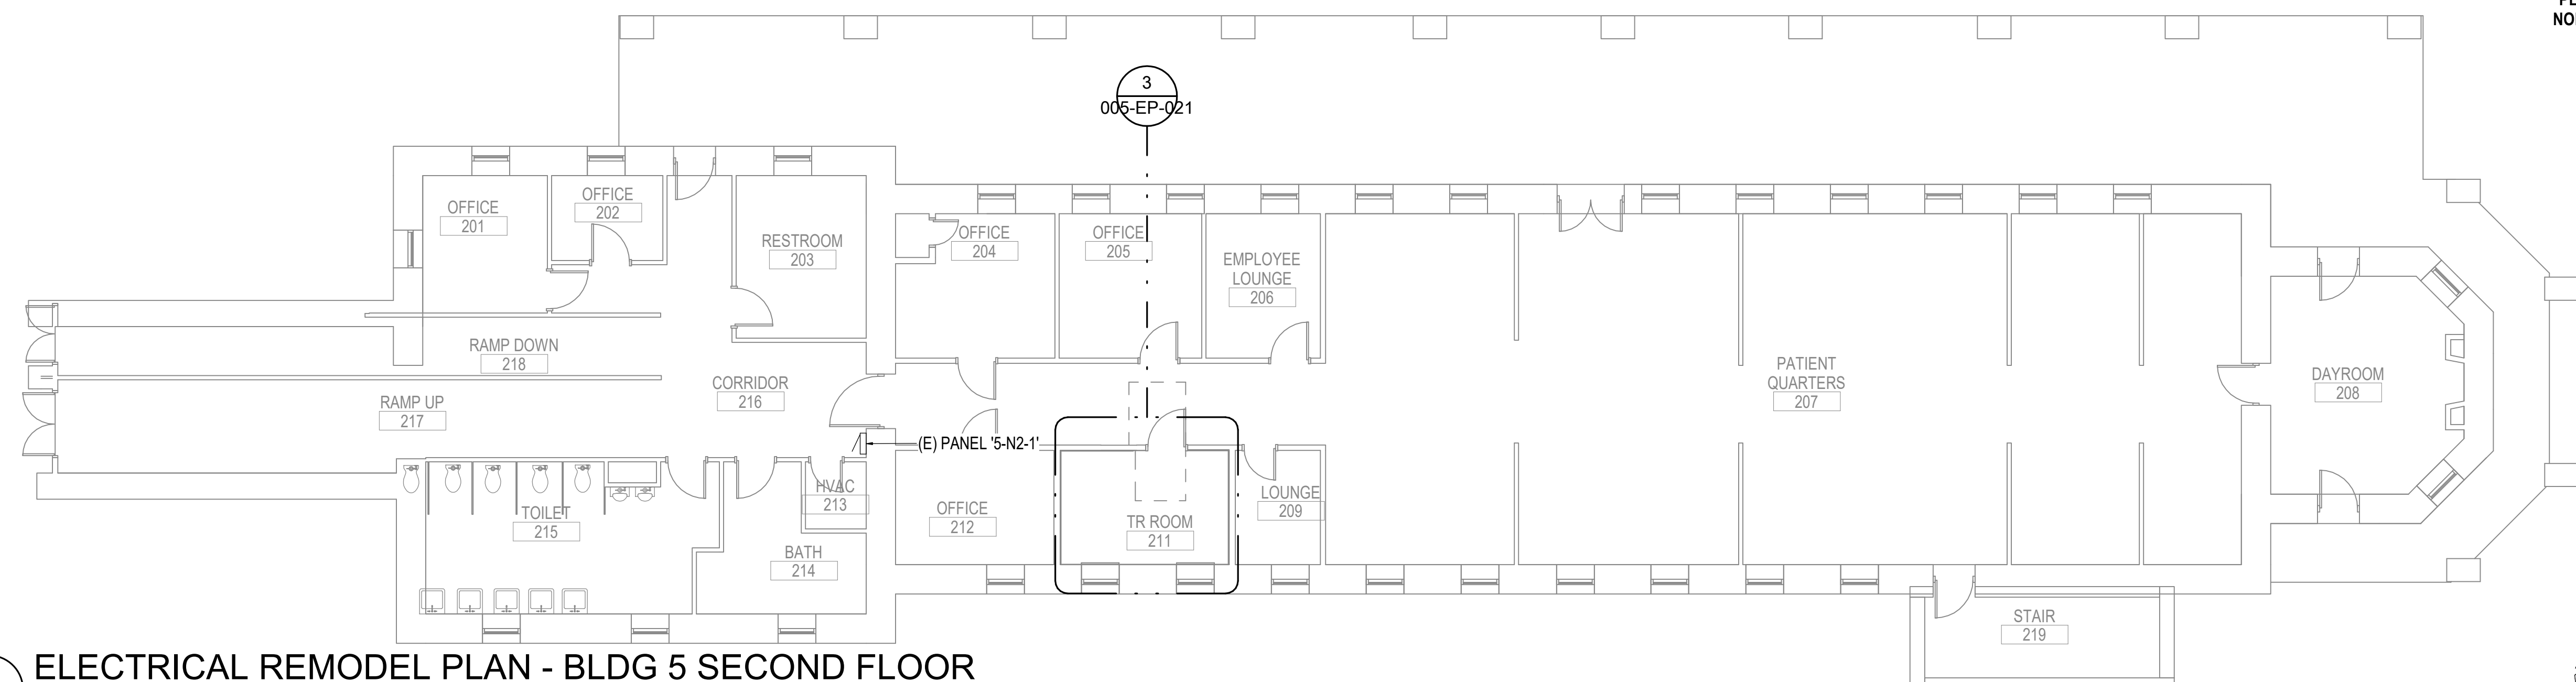

1 ELECTRICAL REMODEL PLAN - BLDG 5 SECOND FLOOR
1/8" = 1'-0"

SITE LEGEND

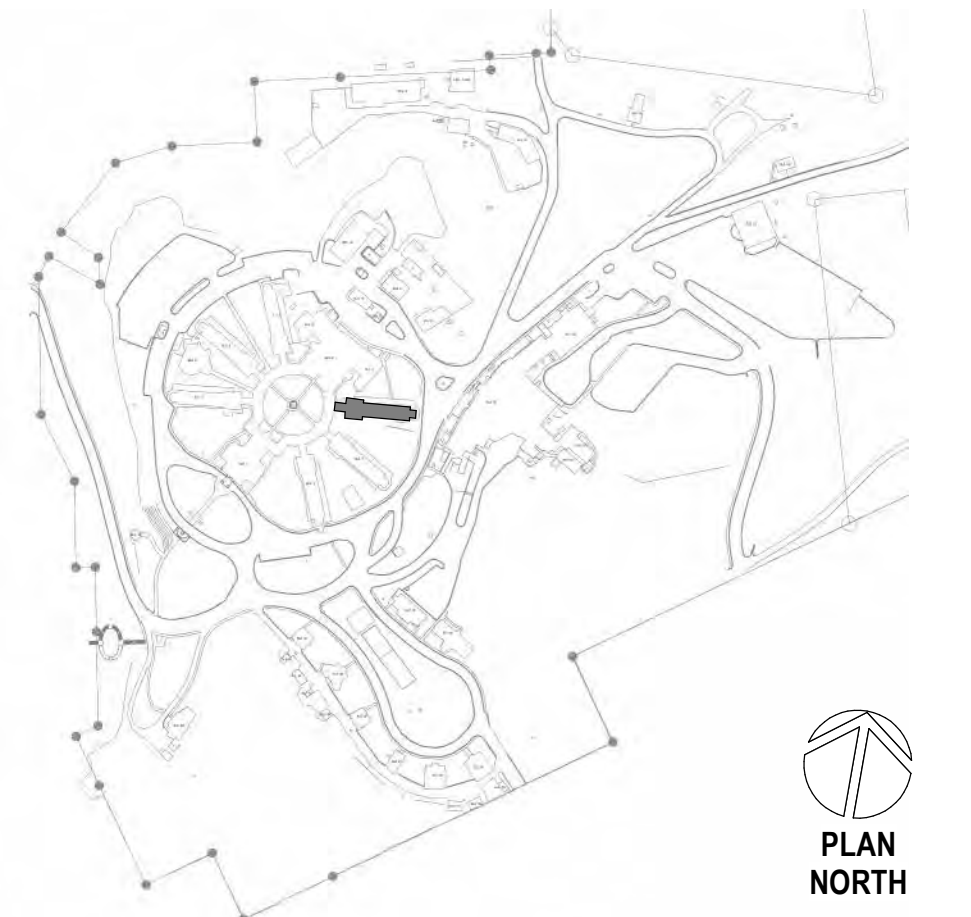[illegible]

CONSULTANT

A/E:
GDM
1000 W STEUBEN ST. UNIT 3
BINGEN, WA 98605
541.436.4723
ADAM GOODIN, PE

GDM
ARCHITECTS • ENGINEERS

ARCHITECT/ENGINEER OF RECORD

R S A

Engineering, Inc.

MECHANICAL AND ELECTRICAL CONSULTING ENGINEERS
670 West Fireweed Lane, Suite 200
Anchorage, AK 99503
Phone (907) 276-0521
Corporate No.: AECC542

**PROGRAM
CONTRACTING
ACTIVITY
CENTRAL (PCAC)**

VA U.S. Department
of Veterans Affairs

DRAWING TITLE

ELECTRICAL REMODEL PLAN -
BLDG 5 SECOND FLOOR

APPROVED: Project Director

PHASE	100% CD FINAL SOLUTION
FLS	FULLY SPRINKLERED

PROJECT TITLE			PROJECT NUMBER	
EHRM INFRASTRUCTURE UPGRADES			568A4-21-702	
LOCATION			BUILDING NUMBER	
HOT SPRINGS, SOUTH DAKOTA			05	
ISSUE DATE			DRAWING NUMBER	
02/22/2022			005-EP-021	
CHECKED BY	DRAWN BY			
JAM	CSZ			

A

B

C

D

E

F

2/22/2022 8:21:16 PM

C:\Users\Caleb\AppData\Local\Microsoft\REVIT\2020\LOCALS\1121\ESRIES-BLDG 6-206.dwg

T

A

B

C

D

E

F

EQUIPMENT SCHEDULE - BUILDING 6

ID TAG	EQUIPMENT DESCRIPTION	ELECTRICAL DATA						REQUIRES DISCONNECT	PANEL / CIRCUIT	CONDUIT / CONDUCTOR SIZE	NOTES
		HP	AMP	WATT	VA	VOLT	Ø				
6-IU-1	AC INDOOR UNIT	-	34.2	-	-	208	1	X	6-N1-T1-7,9	0.75" C, 2#6, 1#10 GND	INTEGRAL CONTROLLER
6-CU-1	CONDENSING UNIT	-	20.5	-	-	208	1	X	6-N1-T1-11,13	0.75" C, 2#10, 1#10 GND	INTEGRAL CONTROLLER
6-DDC-1	DDC FOR INDOOR UNIT	-	-	50	-	120	1	N/A	6-EQ1-T1-4	0.75" C, 1#12, 1#12 NEUT, 1#12 GND	COORDINATE WITH MECH FOR LOCATION
RK-102-1A	TELECOM RACK RECEPTACLE	-	-	5000	-	208	3	N/A	6-EQ1-T1-1,3,5	0.75" C, 3#12, 1#10 NEUT, 1#12 GND	PROVIDE NEMA L21-20R, SEE 5/000-J-001
RK-102-1B	TELECOM RACK RECEPTACLE	-	-	5000	-	208	3	N/A	6-N1-T1-1,3,5	0.75" C, 3#12, 1#10 NEUT, 1#12 GND	PROVIDE NEMA L21-20R, SEE 5/000-J-001
6-RECP-1	CONVENIENCE RECEPTACLE	-	-	-	180	120	1	N/A	6-N1-T1-2	0.75" C, 2#12, 1#12 GND	PROVIDE GFCI, WEATHERPROOF CONVENIENCE RECEPTACLE

GENERAL NOTES:



- A. SEE EQUIPMENT SCHEDULE ON THIS SHEET FOR POWER REQUIREMENTS.
- B. COORDINATE LIGHTING LAYOUT WITH RACK AND CABLE TRAY LOCATIONS TO PROVIDE ILLUMINATION ON EQUIPMENT PER LIGHTING DESIGN REQUIREMENTS.
- C. COORDINATE WITH MECHANICAL DRAWINGS FOR EQUIPMENT LOCATIONS AND CONDUIT/PIPE ROUTING PRIOR TO ROUGH-IN.

SHEET NOTES:

1. PROVIDE RACEWAY AND BOXES FOR ACCESS CONTROLS SYSTEM COMPONENTS. SEE EK-104 FOR TYPICAL DOOR DETAIL.


2 ENLARGED ROOM - 115 ELECTRICAL REMODEL

1/2" = 1'-0"

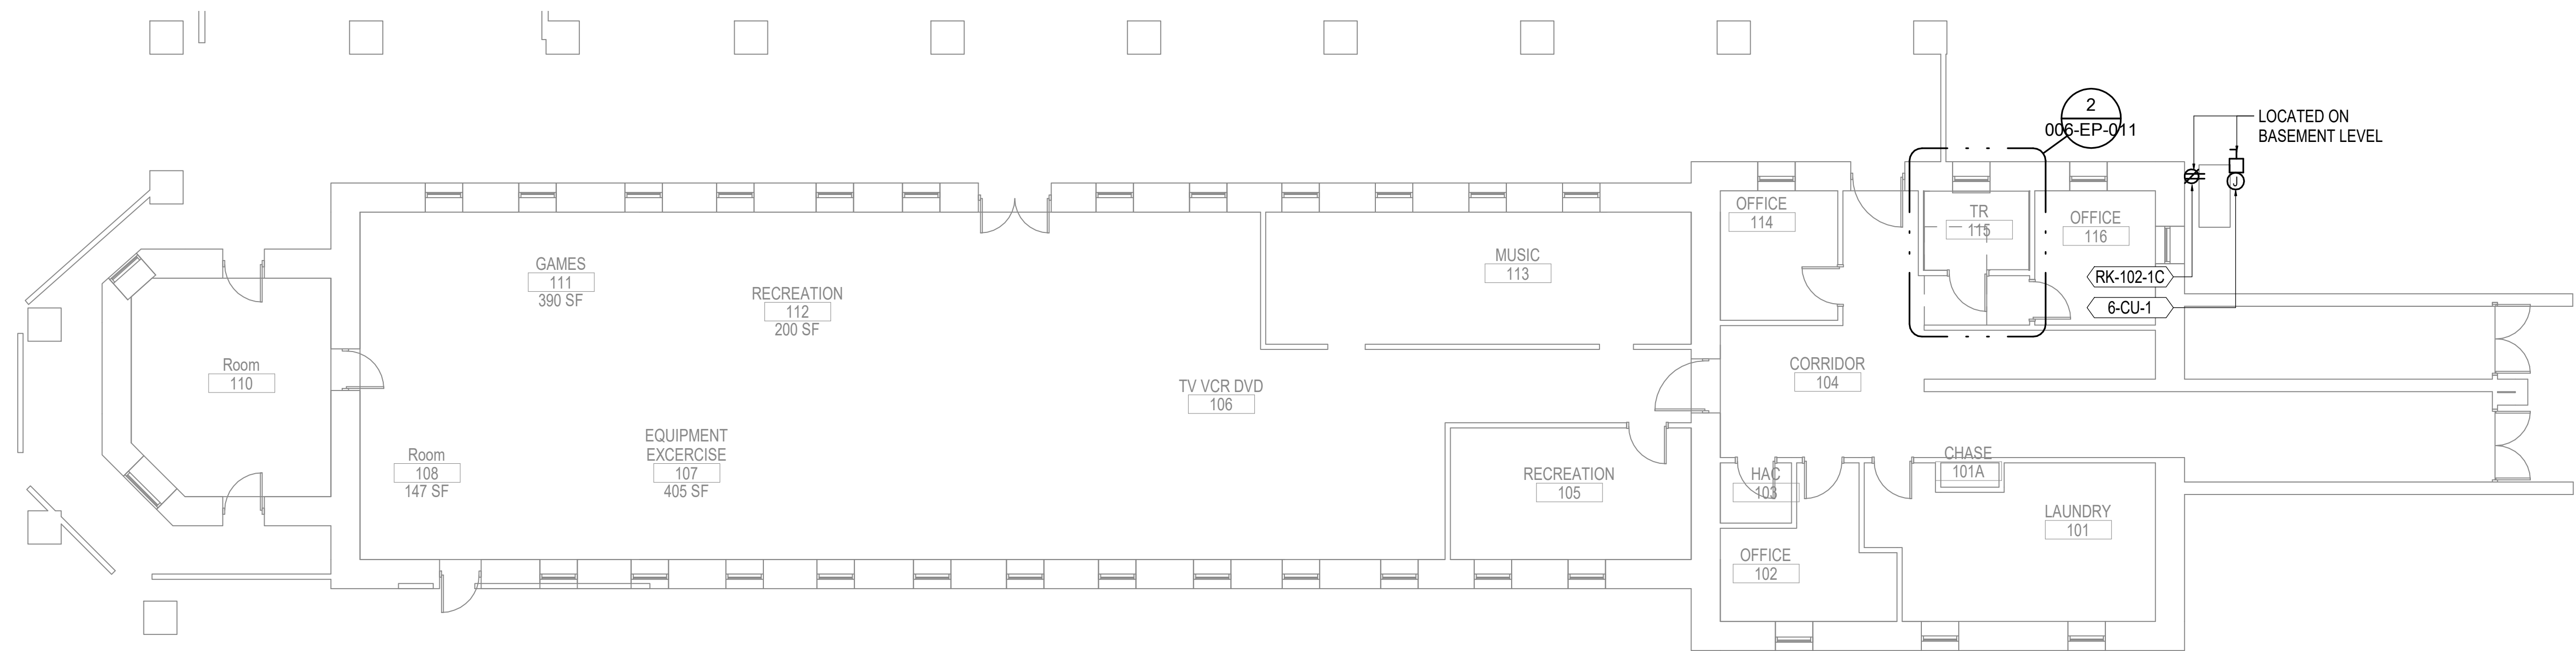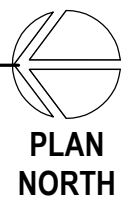


1 ELECTRICAL REMODEL PLAN - BLDG 6 FIRST FLOOR

1/8" = 1'-0"

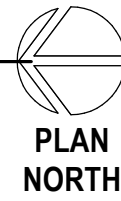

SITE LEGEND

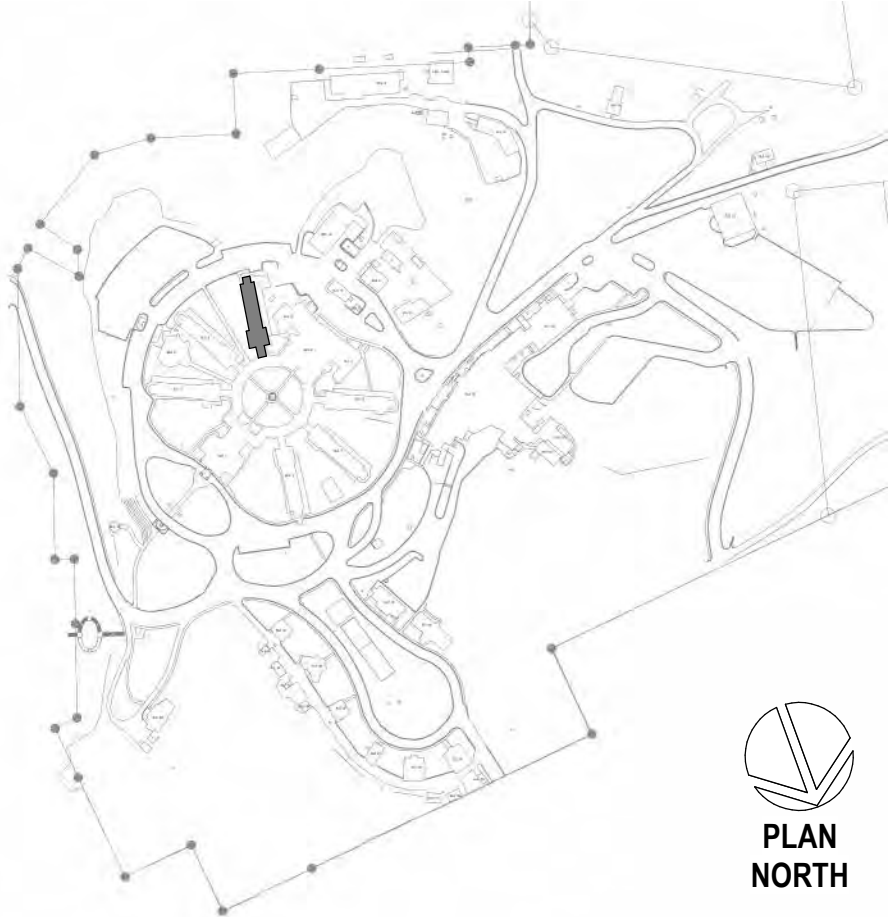

Revisions:	Date:

CONSULTANT

A/E:
GDM
1000 W STEUBEN ST. UNIT 3
BINGEN, WA 98605
541.436.4723
ADAM GOODIN, PE

GDM
ARCHITECTS • ENGINEERS

ARCHITECT/ENGINEER OF RECORD

RSA
Engineering, Inc.
MECHANICAL AND ELECTRICAL CONSULTING ENGINEERS
670 West Firerweed Lane, Suite 200
Anchorage, AK 99503
Phone: (907) 278-0521
Corporate No.: AECC542

STAMP

STATE OF ALASKA
JEREMY A. MAXIE
EE-113847
REGISTERED PROFESSIONAL ENGINEER

PROGRAM CONTRACTING ACTIVITY CENTRAL (PCAC)

VA U.S. Department of Veterans Affairs

DRAWING TITLE
ELECTRICAL REMODEL PLAN - BLDG 6 FIRST FLOOR

APPROVED: Project Director

PHASE
100% CD FINAL SOLUTION

FLS
FULLY SPRINKLERED

PROJECT TITLE
EHRM INFRASTRUCTURE UPGRADES

LOCATION
HOT SPRINGS, SOUTH DAKOTA

ISSUE DATE
2/22/2022

CHECKED BY
JAM

DRAWN BY
CSZ

PROJECT NUMBER
568A4-21-702

BUILDING NUMBER
06

DRAWING NUMBER
006-EP-011

B

 
c

- D

1



2/22/2022 6:29:09 PM



VA FORM 08-6231

DRAWING NUMBER

008-EP-011

GENERAL NOTES:

- A. THE INFORMATION SHOWN ON THIS DRAWING IS TAKEN FROM RECORD DRAWINGS AND A NON-DESTRUCTIVE WALK THROUGH OF THE FACILITY. THERE IS NO WARRANTY OR GUARANTEE AS TO THE ACCURACY OF THE INFORMATION SHOWN HERE-IN. THE CONTRACTOR SHALL FIELD VERIFY ALL ITEMS SCHEDULED FOR DEMOLITION PRIOR TO START OF WORK.
- B. THE OWNER SHALL HAVE FIRST RIGHT OF REFUSAL ON ALL SALVAGEABLE MATERIALS. THE CONTRACTOR SHALL DELIVER SALVAGED MATERIALS TO A WAREHOUSE AS DIRECTED BY THE OWNER. THE CONTRACTOR SHALL DISPOSE OF, OFF SITE, ALL UNWANTED MATERIALS.
- C. DASHED OR DOTTED LINES INDICATE ITEMS TO BE REMOVED. SOLID LINES INDICATE EXISTING ITEMS TO REMAIN.

SHEET NOTES:

1. AT CONTRACTOR'S OPTION EXISTING CONDUIT MAY BE SALVAGED BETWEEN MAIN SWITCHBOARD AND TRANSFER SWITCH IF APPROPRIATELY SIZED. SEE ONE-LINE DIAGRAM FOR NEW FEEDER SIZE.
2. SALVAGE CIRCUIT FOR CONNECTION TO NEW BATTERY CHARGER IN EXISTING LOCATION.
3. PROVIDE EXTENSION OF EXISTING CIRCUIT TO NEW CHARGER IN EXISTING LOCATION. PROVIDE JUNCTION BOXES, CONDUIT, AND WIRE AS REQUIRED.
4. 50 GALLON DAY TANK WITH INTEGRAL CONTROLS, AND LEVEL SWITCHES, ALARMS, ALARMS, DUPLEX POWER SUPPLY PUMPS AND (1) RETURN PUMP. THE DUPLEX PUMPS ARE CONTROLLED SUCH THAT ONLY ONE MAY RUN AT A TIME. SIMPLEX RELIANT 50 OR APPROVED EQUAL. COORDINATE EXACT CONNECTION REQUIREMENTS WITH EQUIPMENT PROVIDED PRIOR TO INSTALLATION.
5. INSTALL (3) NEW 15A, 1P, CIRCUIT BREAKERS IN SPACE AVAILABLE IN THE EXISTING PANEL. THE EXISTING PANEL IS A WESTINGHOUSE TYPE PRL1, 120/208V, 3Ø, 4W, WITH 100A MAIN LUCS. THE NEW CIRCUIT BREAKERS SHALL BE COMPATIBLE WITH AND LISTED FOR USE IN THE EXISTING PANEL AND SHALL HAVE A MINIMUM SHORT CIRCUIT AIC RATING TO MATCH THE LOWEST RATED EXISTING DEVICE IN THE PANEL.
6. ANY ALARM OR SHUTDOWN OF GENERATOR TO PROVIDE A TROUBLE ALARM AT THE FIRE ALARM CONTROL PANEL. INSTALL PER MANUFACTURERS INSTRUCTIONS.
7. GENERATOR EMERGENCY POWER SHUT OFF PUSHBUTTON.

1 ELECTRICAL DEMOLITION PLAN - BLDG 10
1/8" = 1'-0"




2 ELECTRICAL REMODEL PLAN - BLDG 10
1/8" = 1'-0"



EQUIPMENT SCHEDULE - BUILDING 10

ID TAG	EQUIPMENT DESCRIPTION	ELECTRICAL DATA						REQUIRES DISCONNECT	PANEL / CIRCUIT	CONDUIT / CONDUCTOR SIZE	NOTES
		HP	AMP	WATT	VA	VOLT	Ø				
10-UH-1	UNIT HEATER	-	104.2	-	-	208	3	X	SEE ONE-LINE, SHEET EK-102	1.5"Ø, 3Ø1, 1Ø6 GND	COORDINATE WITH MECH FOR LOCATION
10-UH-2	UNIT HEATER	-	104.2	-	-	208	3	X	SEE ONE-LINE, SHEET EK-102	1.5"Ø, 3Ø1, 1Ø6 GND	COORDINATE WITH MECH FOR LOCATION

SITE LEGEND

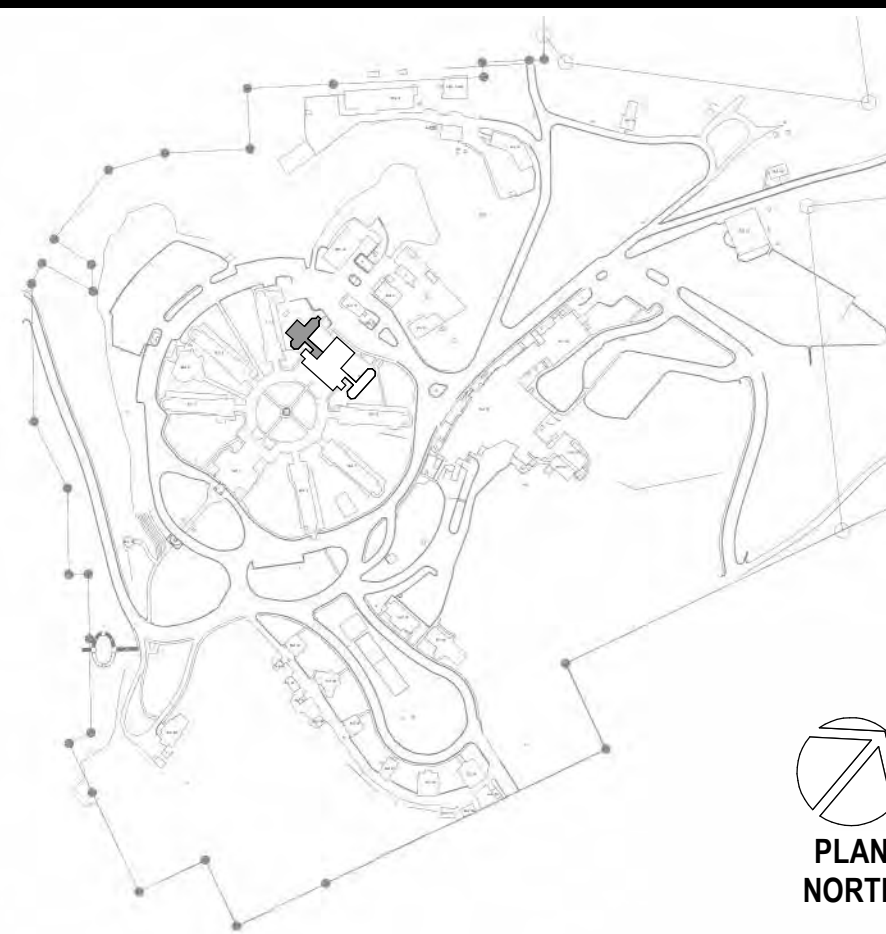

Revisions:	Date:

CONSULTANT

A/E:
GDM
1000 W STEUBEN STR, UNIT 3
BINGEN, WA 98605
541.436.4723
ADAM GOODIN, PE

GDM
ARCHITECTS • ENGINEERS

ARCHITECT/ENGINEER OF RECORD

RSA
Engineering, Inc.
MECHANICAL AND ELECTRICAL CONSULTING ENGINEERS
670 West Firwood Lane, Suite 200
Anchorage, AK 99503
Phone (907) 278-0521
Corporate No.: AECC542

STAMP

STATE OF ALASKA
JEREMY A. MAXIE
REGISTERED PROFESSIONAL ENGINEER
No. 113847
EXPIRATION DATE 8/10/25

PROGRAM CONTRACTING ACTIVITY CENTRAL (PCAC)

VA U.S. Department of Veterans Affairs

DRAWING TITLE
BUILDING 10 ELECTRICAL PLANS

APPROVED: Project Director

PHASE
100% CD FINAL SOLUTION

FLS
FULLY SPRINKLERED

PROJECT TITLE
EHRM INFRASTRUCTURE UPGRADES

LOCATION
HOT SPRINGS, SOUTH DAKOTA

ISSUE DATE
02/22/2022

CHECKED BY
JAM

DRAWN BY
PCC

PROJECT NUMBER
568A4-21-702

BUILDING NUMBER
N/A

DRAWING NUMBER
010-EP-0B1

A

B

C

D


E

F

C:\Users\Calab\AppData\Local\Microsoft\Windows\Temporary Internet Files\Content.IE5\B06Q6E7M\121-EP-081D.dwg 2/22/2022 8:48:17 PM 121-EP-081A

GENERAL NOTES:


- A. SEE EQUIPMENT SCHEDULE ON THIS SHEET FOR POWER REQUIREMENTS.
- B. COORDINATE LIGHTING LAYOUT WITH RACK AND CABLE TRAY LOCATIONS TO PROVIDE ILLUMINATION ON EQUIPMENT PER LIGHTING DESIGN REQUIREMENTS.
- C. COORDINATE WITH MECHANICAL DRAWINGS FOR EQUIPMENT LOCATIONS AND CONDUIT/PIPE ROUTING PRIOR TO ROUGH-IN.

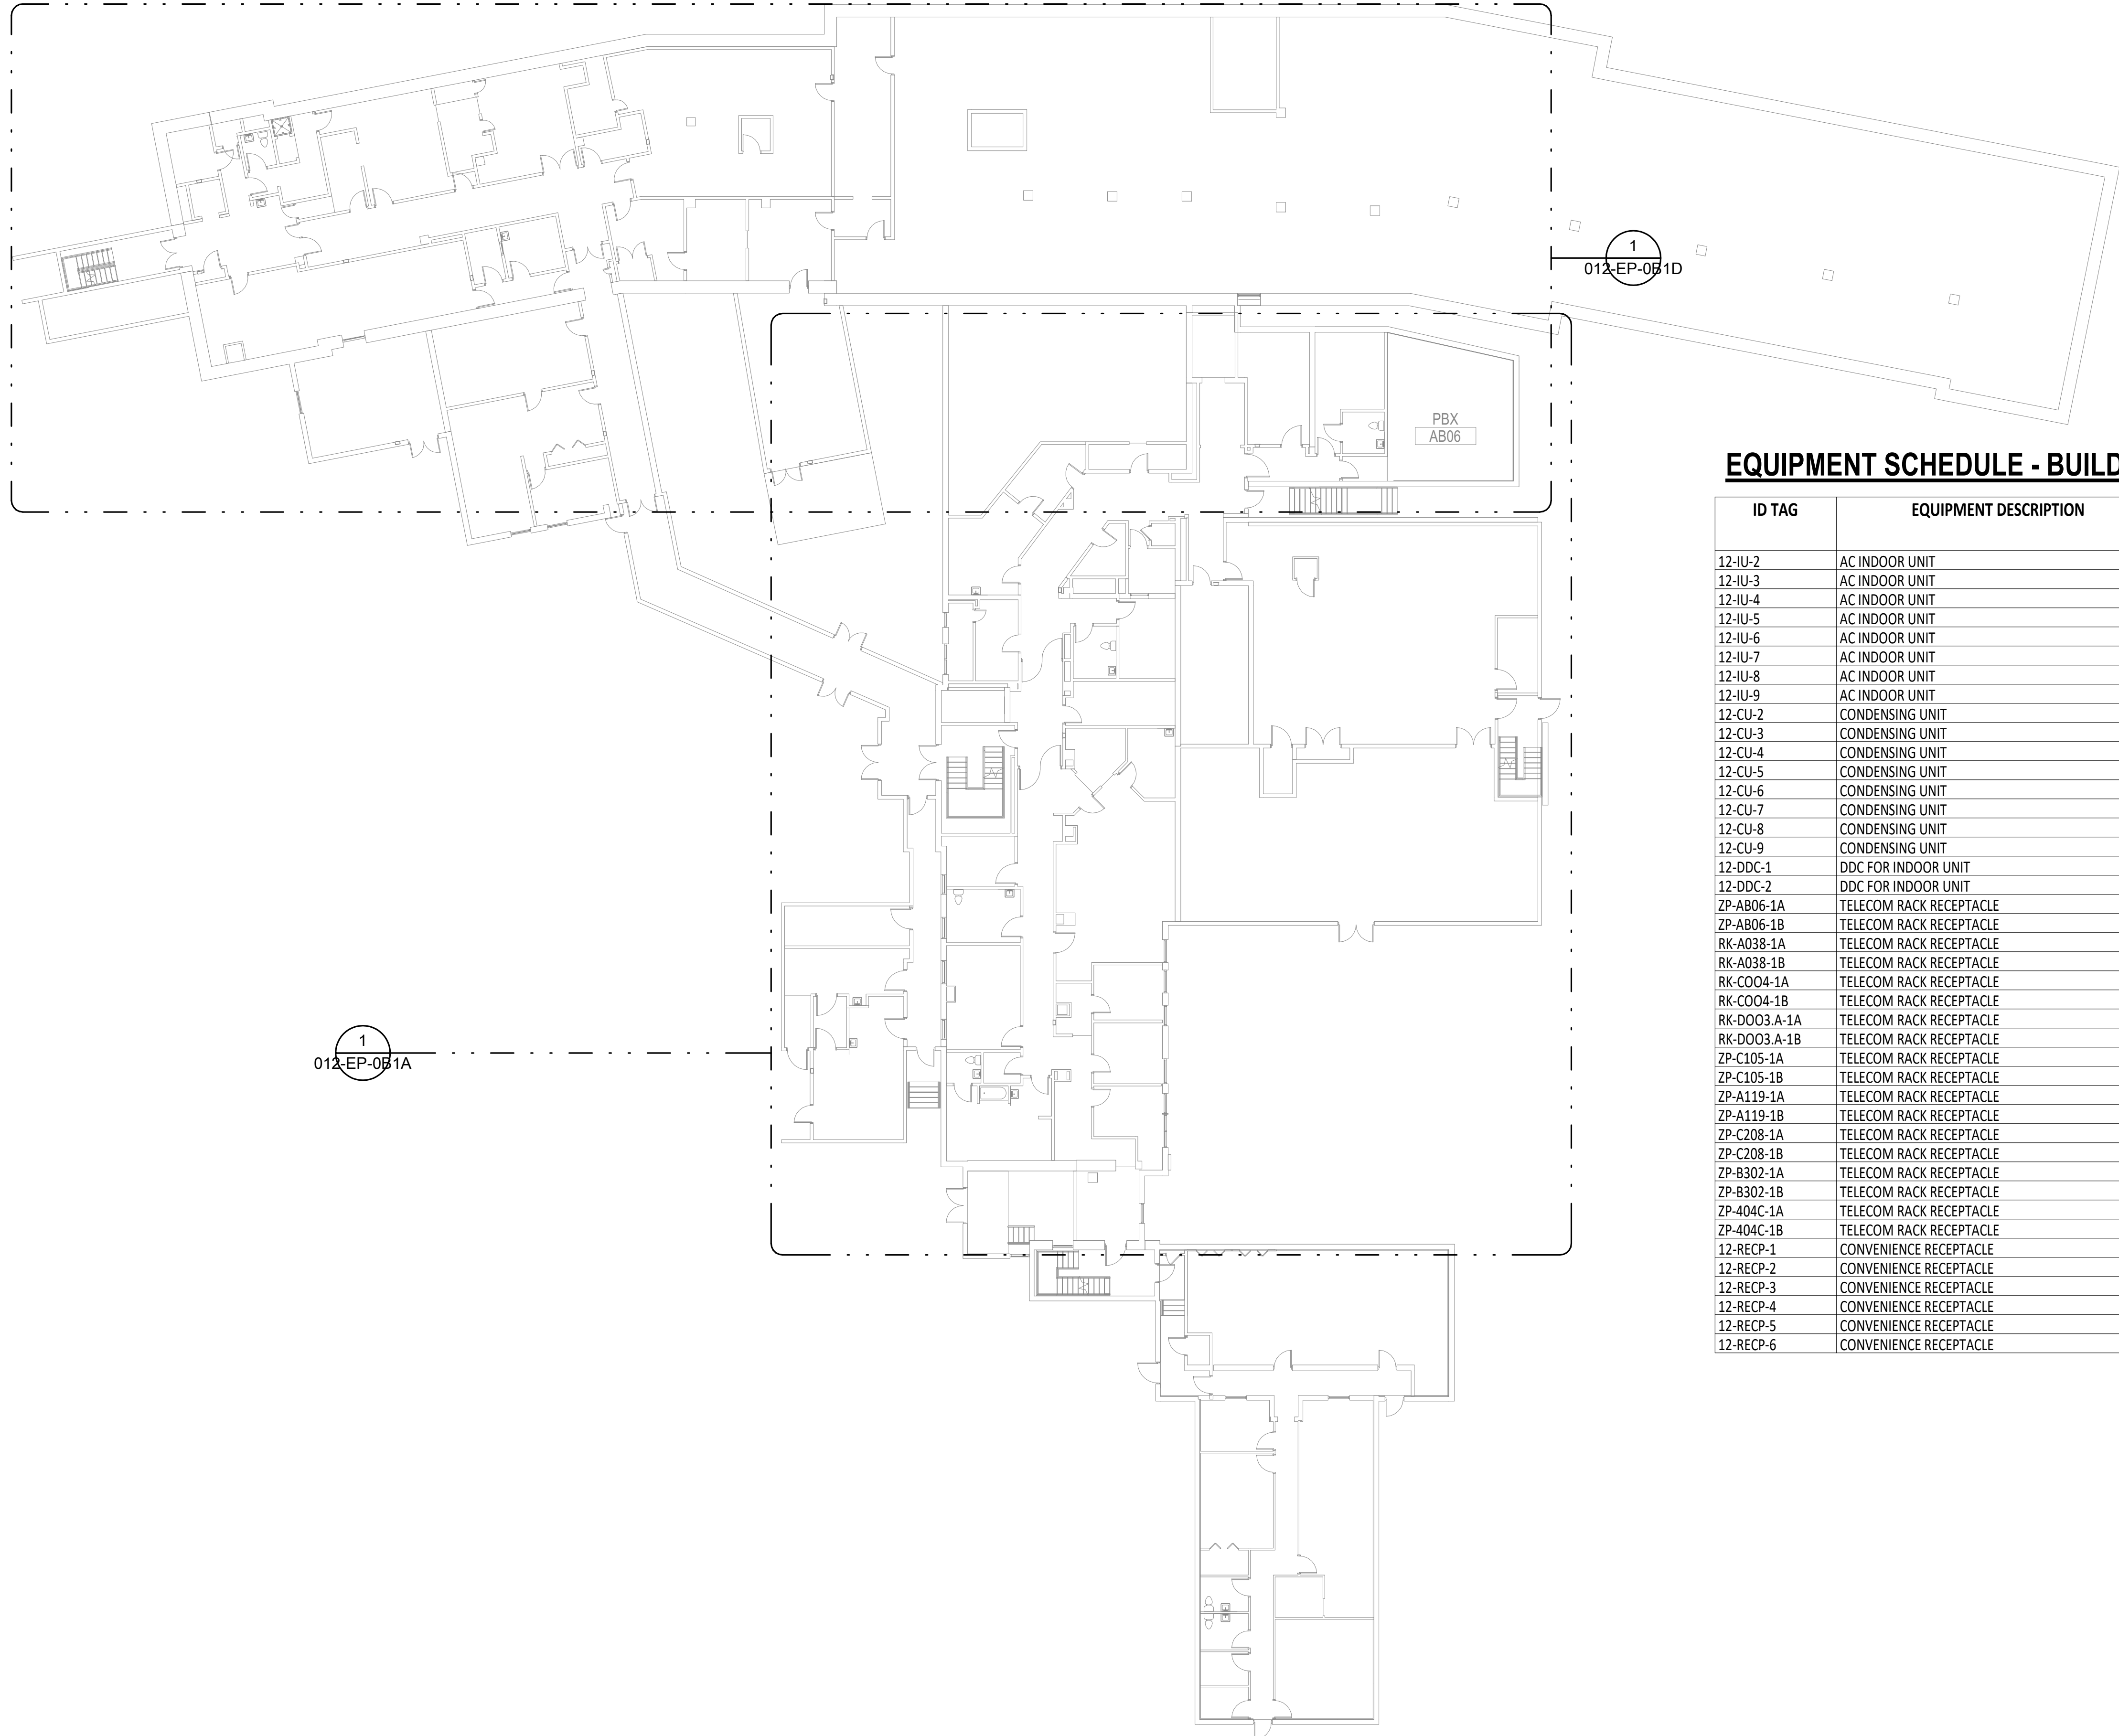


EQUIPMENT SCHEDULE - BUILDING 12

ID TAG	EQUIPMENT DESCRIPTION	ELECTRICAL DATA						REQUIRES DISCONNECT	PANEL / CIRCUIT	CONDUIT / CONDUCTOR SIZE	NOTES	
		HP	AMP	WATT	VA	VOLT	Ø					
12-U-2	AC INDOOR UNIT	-	37.6	-	-	208	3	X	GE-NT1-7,9,11	1" C, 3#6, 1#10 GND	INTEGRAL CONTROLLER	
12-U-3	AC INDOOR UNIT	-	34.2	-	-	208	1	X	GN-NT1-7,9	0.75" C, 2#6, 1#10 GND	INTEGRAL CONTROLLER	
12-U-4	AC INDOOR UNIT	-	34.2	-	-	208	1	X	GN-NT1-15,17	0.75" C, 2#6, 1#10 GND	INTEGRAL CONTROLLER	
12-U-5	AC INDOOR UNIT	-	42.8	-	-	208	3	X	1N-NT1-8,10,12	1" C, 3#6, 1#10 GND	INTEGRAL CONTROLLER	
12-U-6	AC INDOOR UNIT	-	37.6	-	-	208	3	X	1E-NT1-7,9,11	0.75" C, 2#6, 1#10 GND	INTEGRAL CONTROLLER	
12-U-7	AC INDOOR UNIT	-	67.5	-	-	208	3	X	2N-NT1-7,9,11	1.25" C, 3#3, 1#8 GND	INTEGRAL CONTROLLER	
12-U-8	AC INDOOR UNIT	-	42.8	-	-	208	3	X	3N-NT1-7,9,11	1" C, 3#6, 1#10 GND	INTEGRAL CONTROLLER	
12-U-9	AC INDOOR UNIT	-	67.5	-	-	208	3	X	4N-NT1-7,9,11	1.25" C, 3#3, 1#8 GND	INTEGRAL CONTROLLER	
12-CU-2	CONDENSING UNIT	-	3	-	-	208	3	X	GE-NT1-13,15,17	0.75" C, 3#12, 1#12 GND	INTEGRAL CONTROLLER	
12-CU-3	CONDENSING UNIT	-	20.5	-	-	208	1	X	GN-NT1-11,13	0.75" C, 2#10, 1#10 GND	INTEGRAL CONTROLLER	
12-CU-4	CONDENSING UNIT	-	20.5	-	-	208	1	X	GN-NT1-18,20	0.75" C, 2#10, 1#10 GND	INTEGRAL CONTROLLER	
12-CU-5	CONDENSING UNIT	-	23.4	-	-	208	3	X	1N-NT1-15,16,18	0.75" C, 3#10, 1#10 GND	INTEGRAL CONTROLLER	
12-CU-6	CONDENSING UNIT	-	3	-	-	208	3	X	1E-NT1-13,15,17	0.75" C, 3#12, 1#12 GND	INTEGRAL CONTROLLER	
12-CU-7	CONDENSING UNIT	-	3	-	-	208	3	X	2N-NT1-13,15,17	0.75" C, 3#12, 1#12 GND	INTEGRAL CONTROLLER	
12-CU-8	CONDENSING UNIT	-	23.4	-	-	208	3	X	3N-NT1-13,15,17	0.75" C, 3#10, 1#10 GND	INTEGRAL CONTROLLER	
12-CU-9	CONDENSING UNIT	-	3	-	-	208	3	X	4N-NT1-13,15,17	0.75" C, 3#12, 1#12 GND	INTEGRAL CONTROLLER	
12-DDC-1	DDC FOR INDOOR UNIT	-	-	50	-	120	1	N/A	GN-EQT1-4	0.75" C, 1#12, 1#12 NEUT, 1#12 GND	COORDINATE WITH MECH FOR LOCATION	
12-DDC-2	DDC FOR INDOOR UNIT	-	-	50	-	120	1	N/A	GN-EQT1-8	0.75" C, 1#12, 1#12 NEUT, 1#12 GND	COORDINATE WITH MECH FOR LOCATION	
ZP-AB06-1A	TELECOM RACK RECEPTACLE	-	-	10000	-	208	3	N/A	BE-LS1-1,3,5	0.75" C, 3#10, 1#8 NEUT, 1#10 GND	PROVIDE NEMA L21-30R, SEE 5/000-J-001	
ZP-AB06-1B	TELECOM RACK RECEPTACLE	-	-	10000	-	208	3	N/A	BE-NT1-1,3,5	0.75" C, 3#10, 1#8 NEUT, 1#10 GND	PROVIDE NEMA L21-30R, SEE 5/000-J-001	
RK-A038-1A	TELECOM RACK RECEPTACLE	-	-	5000	-	208	3	N/A	GE-EQT1-1,3,5	0.75" C, 3#12, 1#10 NEUT, 1#12 GND	PROVIDE NEMA L21-20R, SEE 5/000-J-001	
RK-A038-1B	TELECOM RACK RECEPTACLE	-	-	5000	-	208	3	N/A	GE-NT1-1,3,5	0.75" C, 3#12, 1#10 NEUT, 1#12 GND	PROVIDE NEMA L21-20R, SEE 5/000-J-001	
RK-C004-1A	TELECOM RACK RECEPTACLE	-	-	5000	-	208	3	N/A	GN-EQT1-1,3,5	0.75" C, 3#12, 1#10 NEUT, 1#12 GND	PROVIDE NEMA L21-20R, SEE 5/000-J-001	
RK-C004-1B	TELECOM RACK RECEPTACLE	-	-	5000	-	208	3	N/A	GN-NT1-1,3,5	0.75" C, 3#12, 1#10 NEUT, 1#12 GND	PROVIDE NEMA L21-20R, SEE 5/000-J-001	
RK-DO03-A-1A	TELECOM RACK RECEPTACLE	-	-	5000	-	208	3	N/A	GN-EQT1-7,9,11	0.75" C, 3#12, 1#10 NEUT, 1#12 GND	PROVIDE NEMA L21-20R, SEE 5/000-J-001	
RK-DO03-A-1B	TELECOM RACK RECEPTACLE	-	-	5000	-	208	3	N/A	GN-NT1-10,12,14	0.75" C, 3#12, 1#10 NEUT, 1#12 GND	PROVIDE NEMA L21-20R, SEE 5/000-J-001	
ZP-C105-1A	TELECOM RACK RECEPTACLE	-	-	10000	-	208	3	N/A	1N-EQT1-1,3,5	0.75" C, 3#10, 1#8 NEUT, 1#10 GND	PROVIDE NEMA L21-30R, SEE 5/000-J-001	
ZP-C105-1B	TELECOM RACK RECEPTACLE	-	-	10000	-	208	3	N/A	1N-NT1-1,3,5	0.75" C, 3#10, 1#8 NEUT, 1#10 GND	PROVIDE NEMA L21-30R, SEE 5/000-J-001	
ZP-A119-1A	TELECOM RACK RECEPTACLE	-	-	10000	-	208	3	N/A	1E-EQT1-1,3,5	0.75" C, 3#10, 1#8 NEUT, 1#10 GND	PROVIDE NEMA L21-30R, SEE 5/000-J-001	
ZP-A119-1B	TELECOM RACK RECEPTACLE	-	-	10000	-	208	3	N/A	1E-NT1-1,3,5	0.75" C, 3#10, 1#8 NEUT, 1#10 GND	PROVIDE NEMA L21-30R, SEE 5/000-J-001	
ZP-C208-1A	TELECOM RACK RECEPTACLE	-	-	10000	-	208	3	N/A	2N-EQT1-1,3,5	0.75" C, 3#10, 1#8 NEUT, 1#10 GND	PROVIDE NEMA L21-30R, SEE 5/000-J-001	
ZP-C208-1B	TELECOM RACK RECEPTACLE	-	-	10000	-	208	3	N/A	2N-NT1-1,3,5	0.75" C, 3#10, 1#8 NEUT, 1#10 GND	PROVIDE NEMA L21-30R, SEE 5/000-J-001	
ZP-B302-1A	TELECOM RACK RECEPTACLE	-	-	10000	-	208	3	N/A	3N-EQT1-1,3,5	0.75" C, 3#10, 1#8 NEUT, 1#10 GND	PROVIDE NEMA L21-30R, SEE 5/000-J-001	
ZP-B302-1B	TELECOM RACK RECEPTACLE	-	-	10000	-	208	3	N/A	3N-NT1-1,3,5	0.75" C, 3#10, 1#8 NEUT, 1#10 GND	PROVIDE NEMA L21-30R, SEE 5/000-J-001	
ZP-404C-1A	TELECOM RACK RECEPTACLE	-	-	10000	-	208	3	N/A	4N-EQT1-1,3,5	0.75" C, 3#10, 1#8 NEUT, 1#10 GND	PROVIDE NEMA L21-30R, SEE 5/000-J-001	
ZP-404C-1B	TELECOM RACK RECEPTACLE	-	-	10000	-	208	3	N/A	4N-NT1-1,3,5	0.75" C, 3#10, 1#8 NEUT, 1#10 GND	PROVIDE NEMA L21-30R, SEE 5/000-J-001	
12-RECP-1	CONVENIENCE RECEPTACLE	-	-	-	-	180	120	1	N/A	GE-NT1-8	0.75" C, 2#12, 1#12 GND	PROVIDE GFCI, WEATHERPROOF CONVENIENCE RECEPTACLE
12-RECP-2	CONVENIENCE RECEPTACLE	-	-	-	-	180	120	1	N/A	GN-NT1-8	0.75" C, 2#12, 1#12 GND	PROVIDE GFCI, WEATHERPROOF CONVENIENCE RECEPTACLE
12-RECP-3	CONVENIENCE RECEPTACLE	-	-	-	-	180	120	1	N/A	GN-NT1-2	0.75" C, 2#12, 1#12 GND	PROVIDE GFCI, WEATHERPROOF CONVENIENCE RECEPTACLE
12-RECP-4	CONVENIENCE RECEPTACLE	-	-	-	-	180	120	1	N/A	1E-NT1-8	0.75" C, 2#12, 1#12 GND	PROVIDE GFCI, WEATHERPROOF CONVENIENCE RECEPTACLE
12-RECP-5	CONVENIENCE RECEPTACLE	-	-	-	-	180	120	1	N/A	1N-NT1-19	0.75" C, 2#12, 1#12 GND	PROVIDE GFCI, WEATHERPROOF CONVENIENCE RECEPTACLE
12-RECP-6	CONVENIENCE RECEPTACLE	-	-	-	-	180	120	1	N/A	4N-NT1-8	0.75" C, 2#12, 1#12 GND	PROVIDE GFCI, WEATHERPROOF CONVENIENCE RECEPTACLE

SITE LEGEND

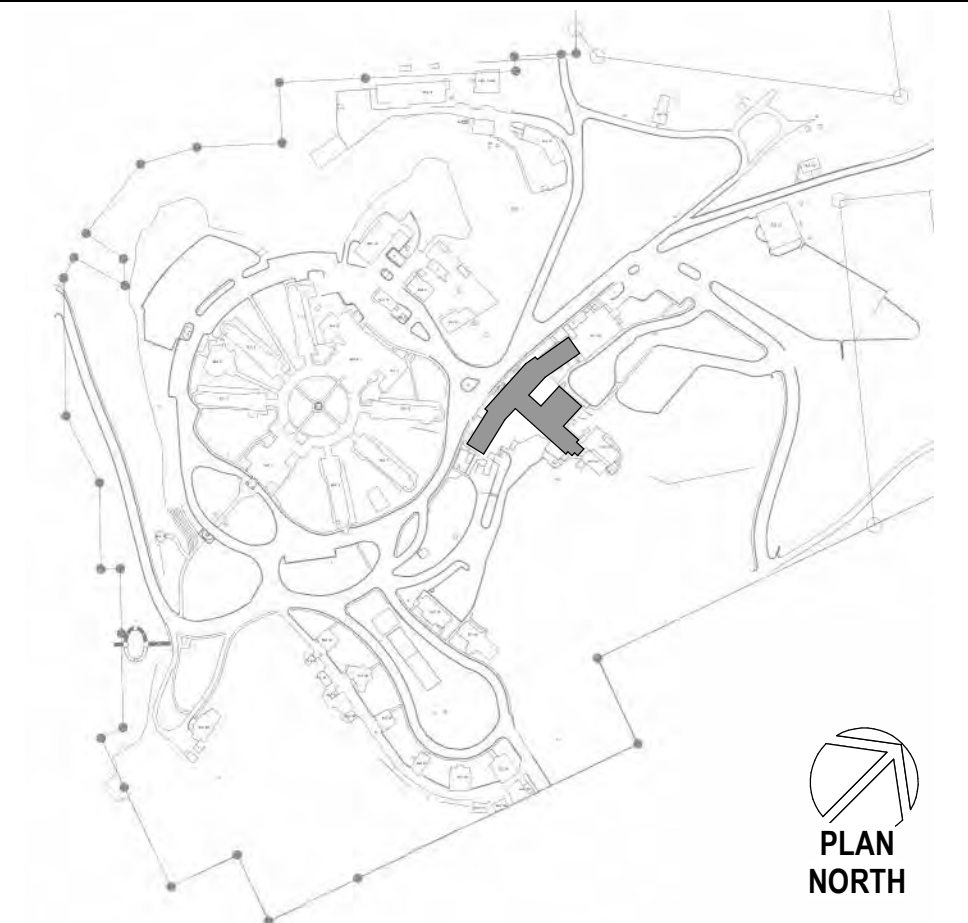

1 ELECTRICAL REMODEL LAYOUT - BLDG 12 BASEMENT
1/16" = 1'-0"

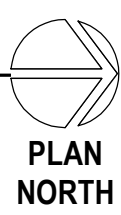

Revisions:	Date:

CONSULTANT

A/E:
GDM
1000 W STEUBEN ST. UNIT 3
BINGEN, WA 98605
541.436.4723
ADAM GOODWIN, PE

GDM
ARCHITECTS • ENGINEERS

ARCHITECT/ENGINEER OF RECORD

RSA
Engineering, Inc.
MECHANICAL AND ELECTRICAL CONSULTING ENGINEERS
670 West Firwood Lane, Suite 200
Anchorage, AK 99503
Phone (907) 276-0521
Corporate No.: AEC0542

STAMP

STATE OF ALASKA
JEREMY A. MAXIE
REGISTERED PROFESSIONAL ENGINEER
No. 11347
EXPIRATION DATE 12/31/2022

PROGRAM CONTRACTING ACTIVITY CENTRAL (PCAC)

VA U.S. Department of Veterans Affairs

DRAWING TITLE

ELECTRICAL REMODEL PLAN - BLDG 12 BASEMENT

APPROVED: Project Director

PHASE

100% CD FINAL SOLUTION

FLS

FULLY SPRINKLERED

PROJECT TITLE

EHRM INFRASTRUCTURE UPGRADES

LOCATION

HOT SPRINGS, SOUTH DAKOTA

ISSUE DATE

2/22/2022

CHECKED BY

JAM

DRAWN BY

CSZ

PROJECT NUMBER


568A4-21-702

BUILDING NUMBER

12

DRAWING NUMBER

012-EP-081

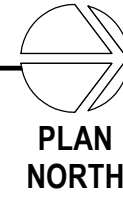

C:\Users\Calab Kopp\Documents\REVIT 2020 LOCALS\1121 ESERIES BLDG 12 r20 ckappCQGETM.rvt

CONSULTANT

A/E:
GDM
1000 W STEUBEN ST. UNIT 3
BINGEN, WA 98605
541.436.4723
ADAM GOODWIN, PE


GDM
ARCHITECTS • ENGINEERS

PROJECT NUMBER	568A4-21-702
BUILDING NUMBER	12
DRAWING NUMBER	012-EP-0B1A



GENERAL NOTES:

A. SEE SHEET 012-EP-0B1 FOR GENERAL NOTES.

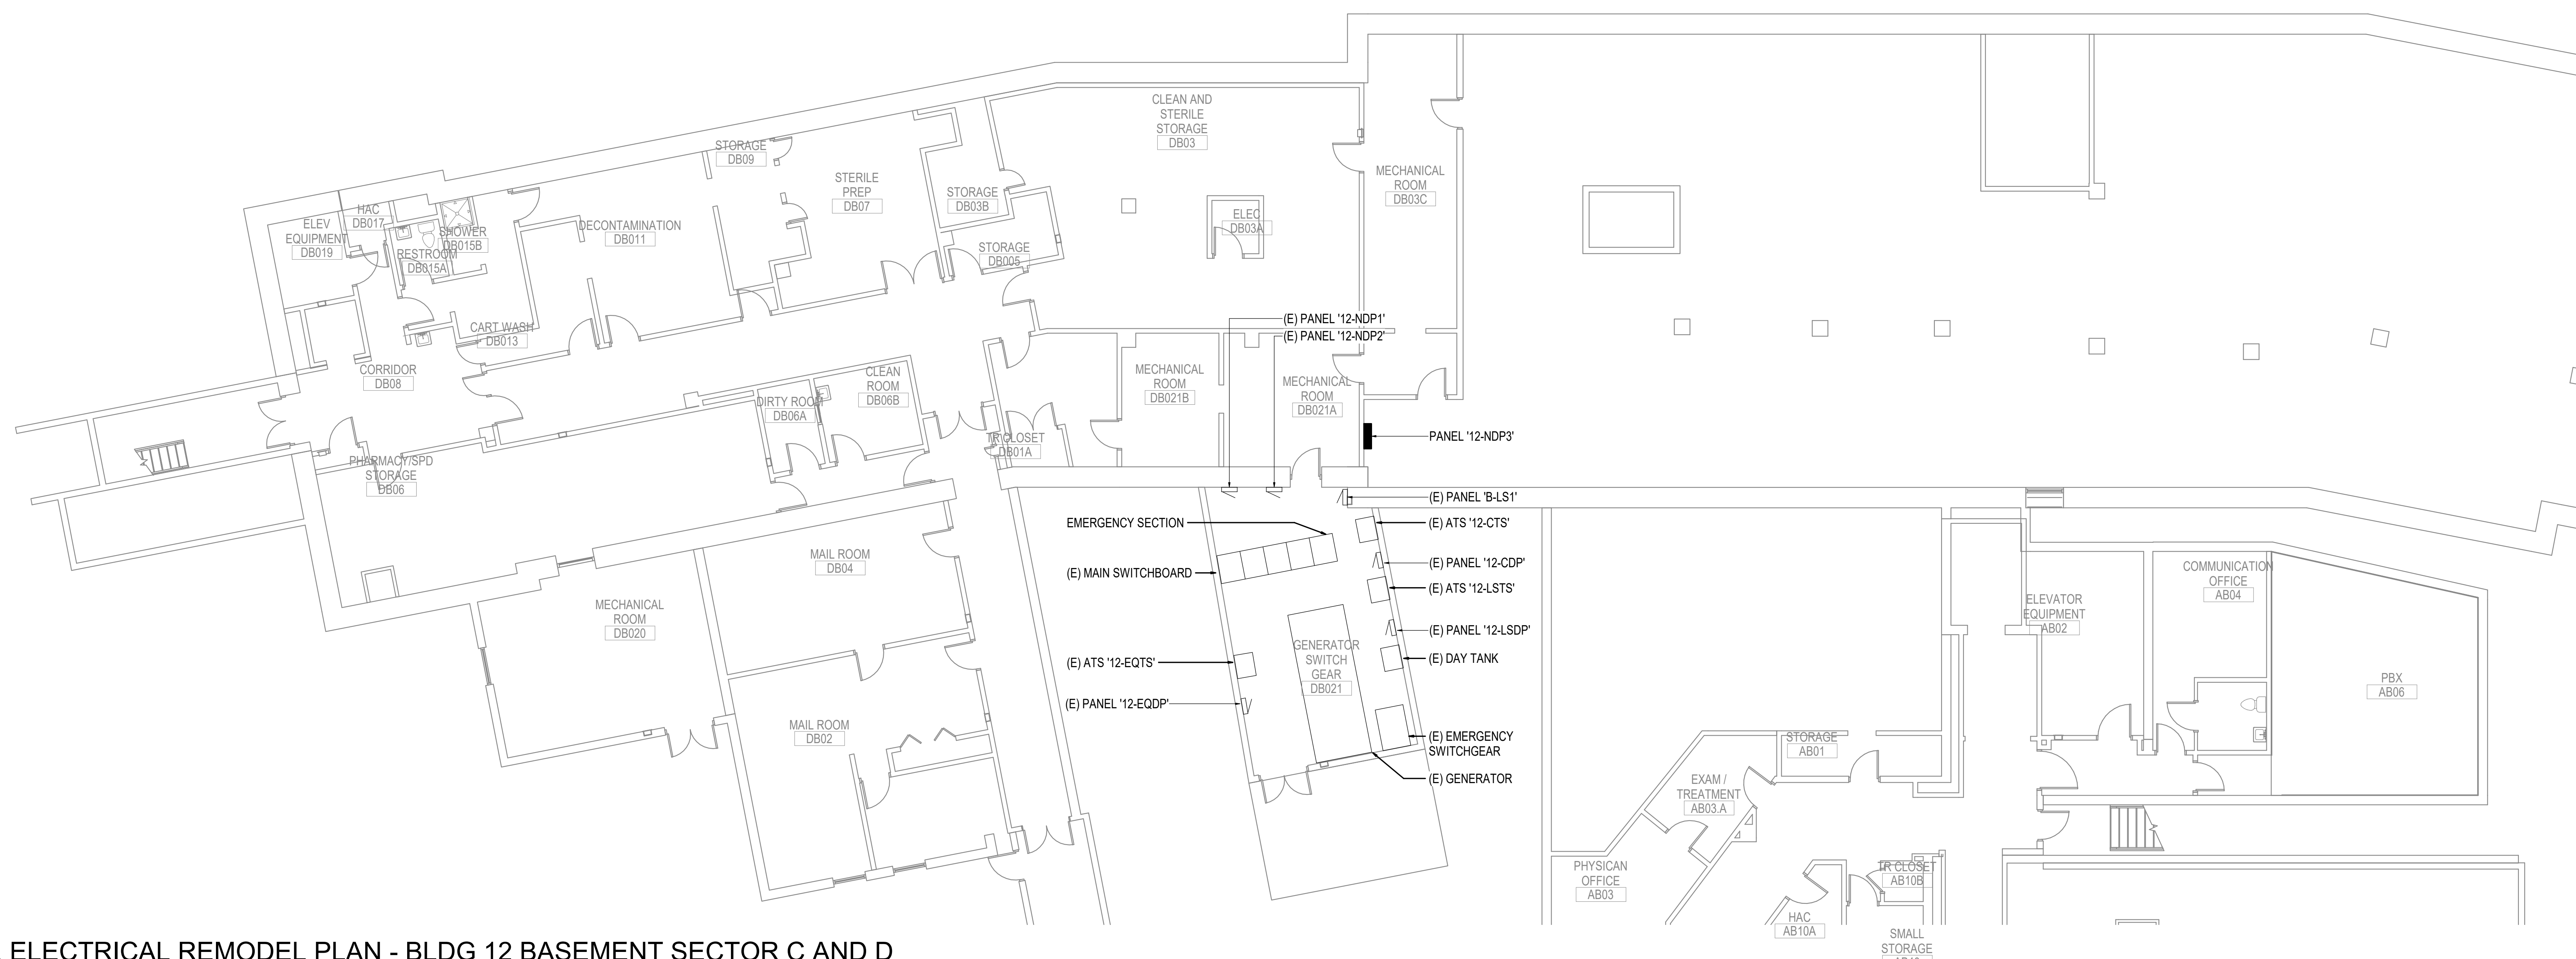

1 ELECTRICAL REMODEL PLAN - BLDG 12 BASEMENT SECTOR C AND D
1/8" = 1'-0"

Revisions:	Date:

CONSULTANT

A/E:
GDM
1000 W STEUBEN ST. UNIT 3
BINGEN, WA 98605
541.436.4723
ADAM GOODWIN, PE

ARCHITECT/ENGINEER OF RECORD

Engineering, Inc.
MECHANICAL AND ELECTRICAL CONSULTING ENGINEERS
670 West Firwood Lane, Suite 200
Anchorage, AK 99503
Phone (907) 278-0521
Corporate No.: AEC0542

STAMP

PROGRAM
CONTRACTING
ACTIVITY
CENTRAL (PCAC)

U.S. Department
of Veterans Affairs

DRAWING TITLE

ELECTRICAL REMODEL - BLDG 12
BASEMENT C/D

APPROVED: Project Director

PHASE

FILE ROOM
AB08
100% CD FINAL SOLUTION

FLS

FULLY SPRINKLERED

PROJECT TITLE

EHRM INFRASTRUCTURE
UPGRADES

LOCATION

HOT SPRINGS, SOUTH DAKOTA

ISSUE DATE

2/22/2022

CHECKED BY

JAM

DRAWN BY

CSZ

PROJECT NUMBER


568A4-21-702

BUILDING NUMBER


12

DRAWING NUMBER

012-EP-0B1D

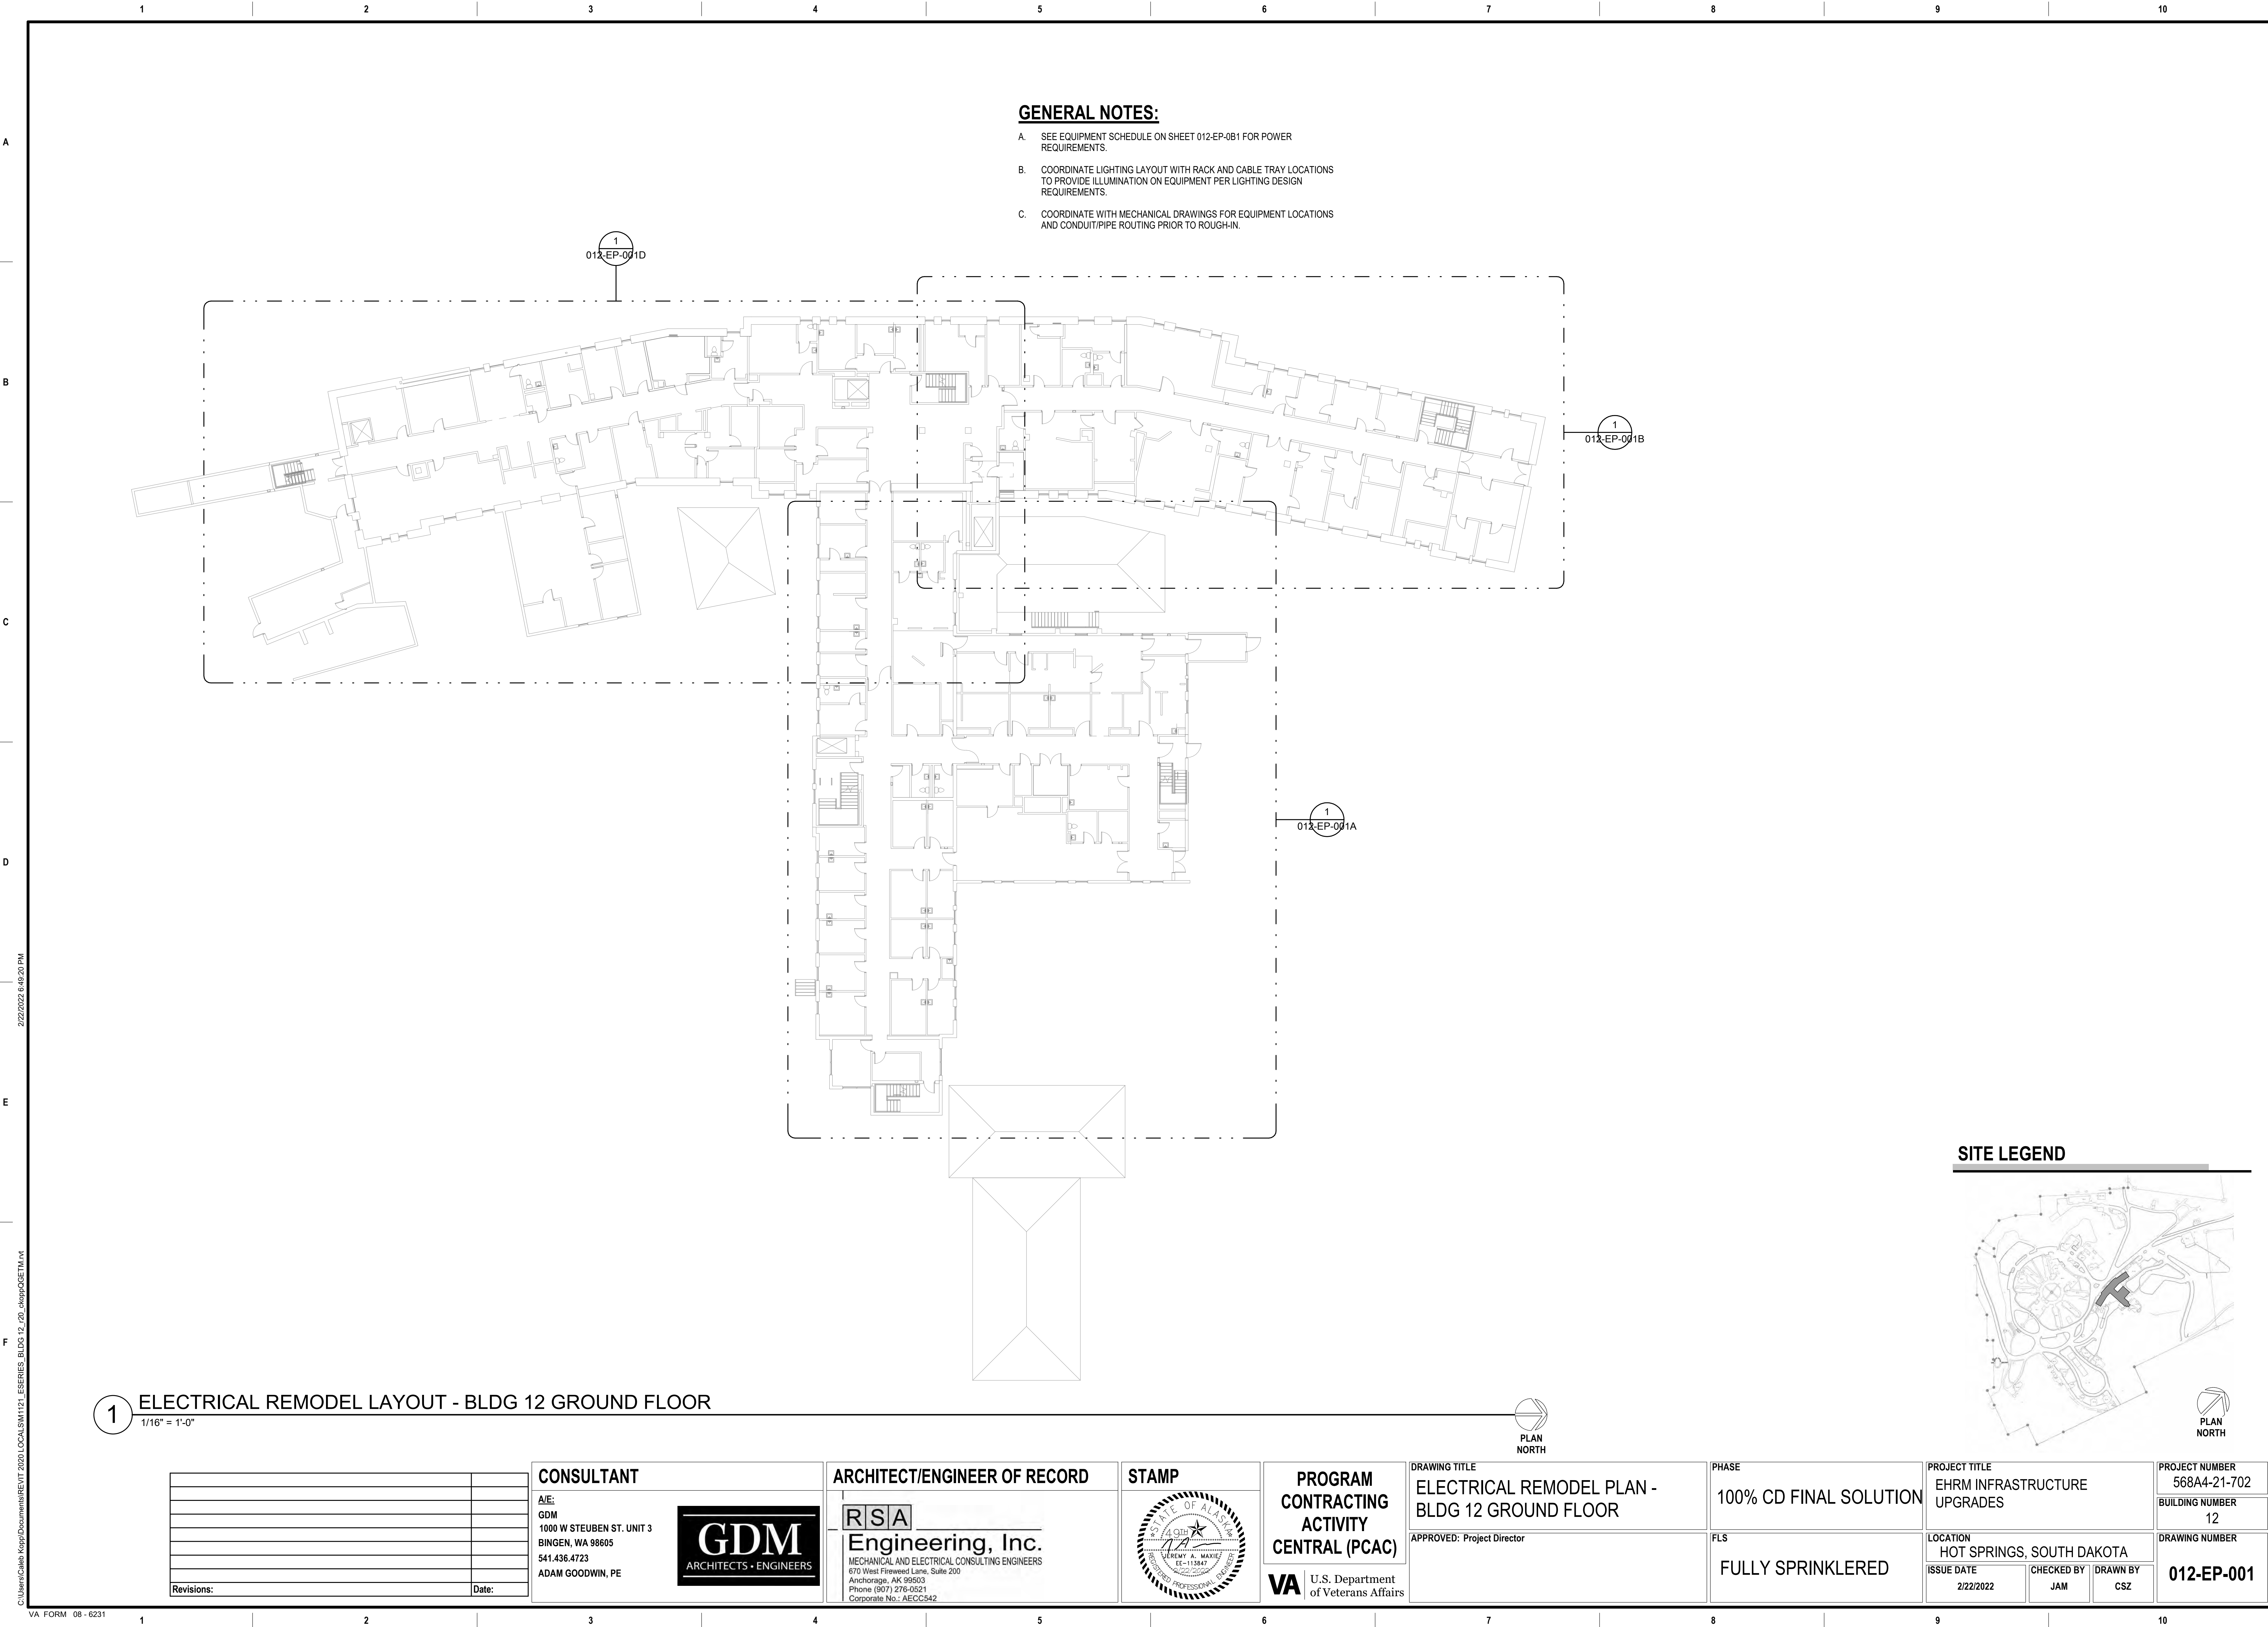

C:\Users\Calab\AppData\Local\Microsoft\Windows\Temporary Internet Files\Content.IE5\B06T6M\20220222 8:49:20 PM

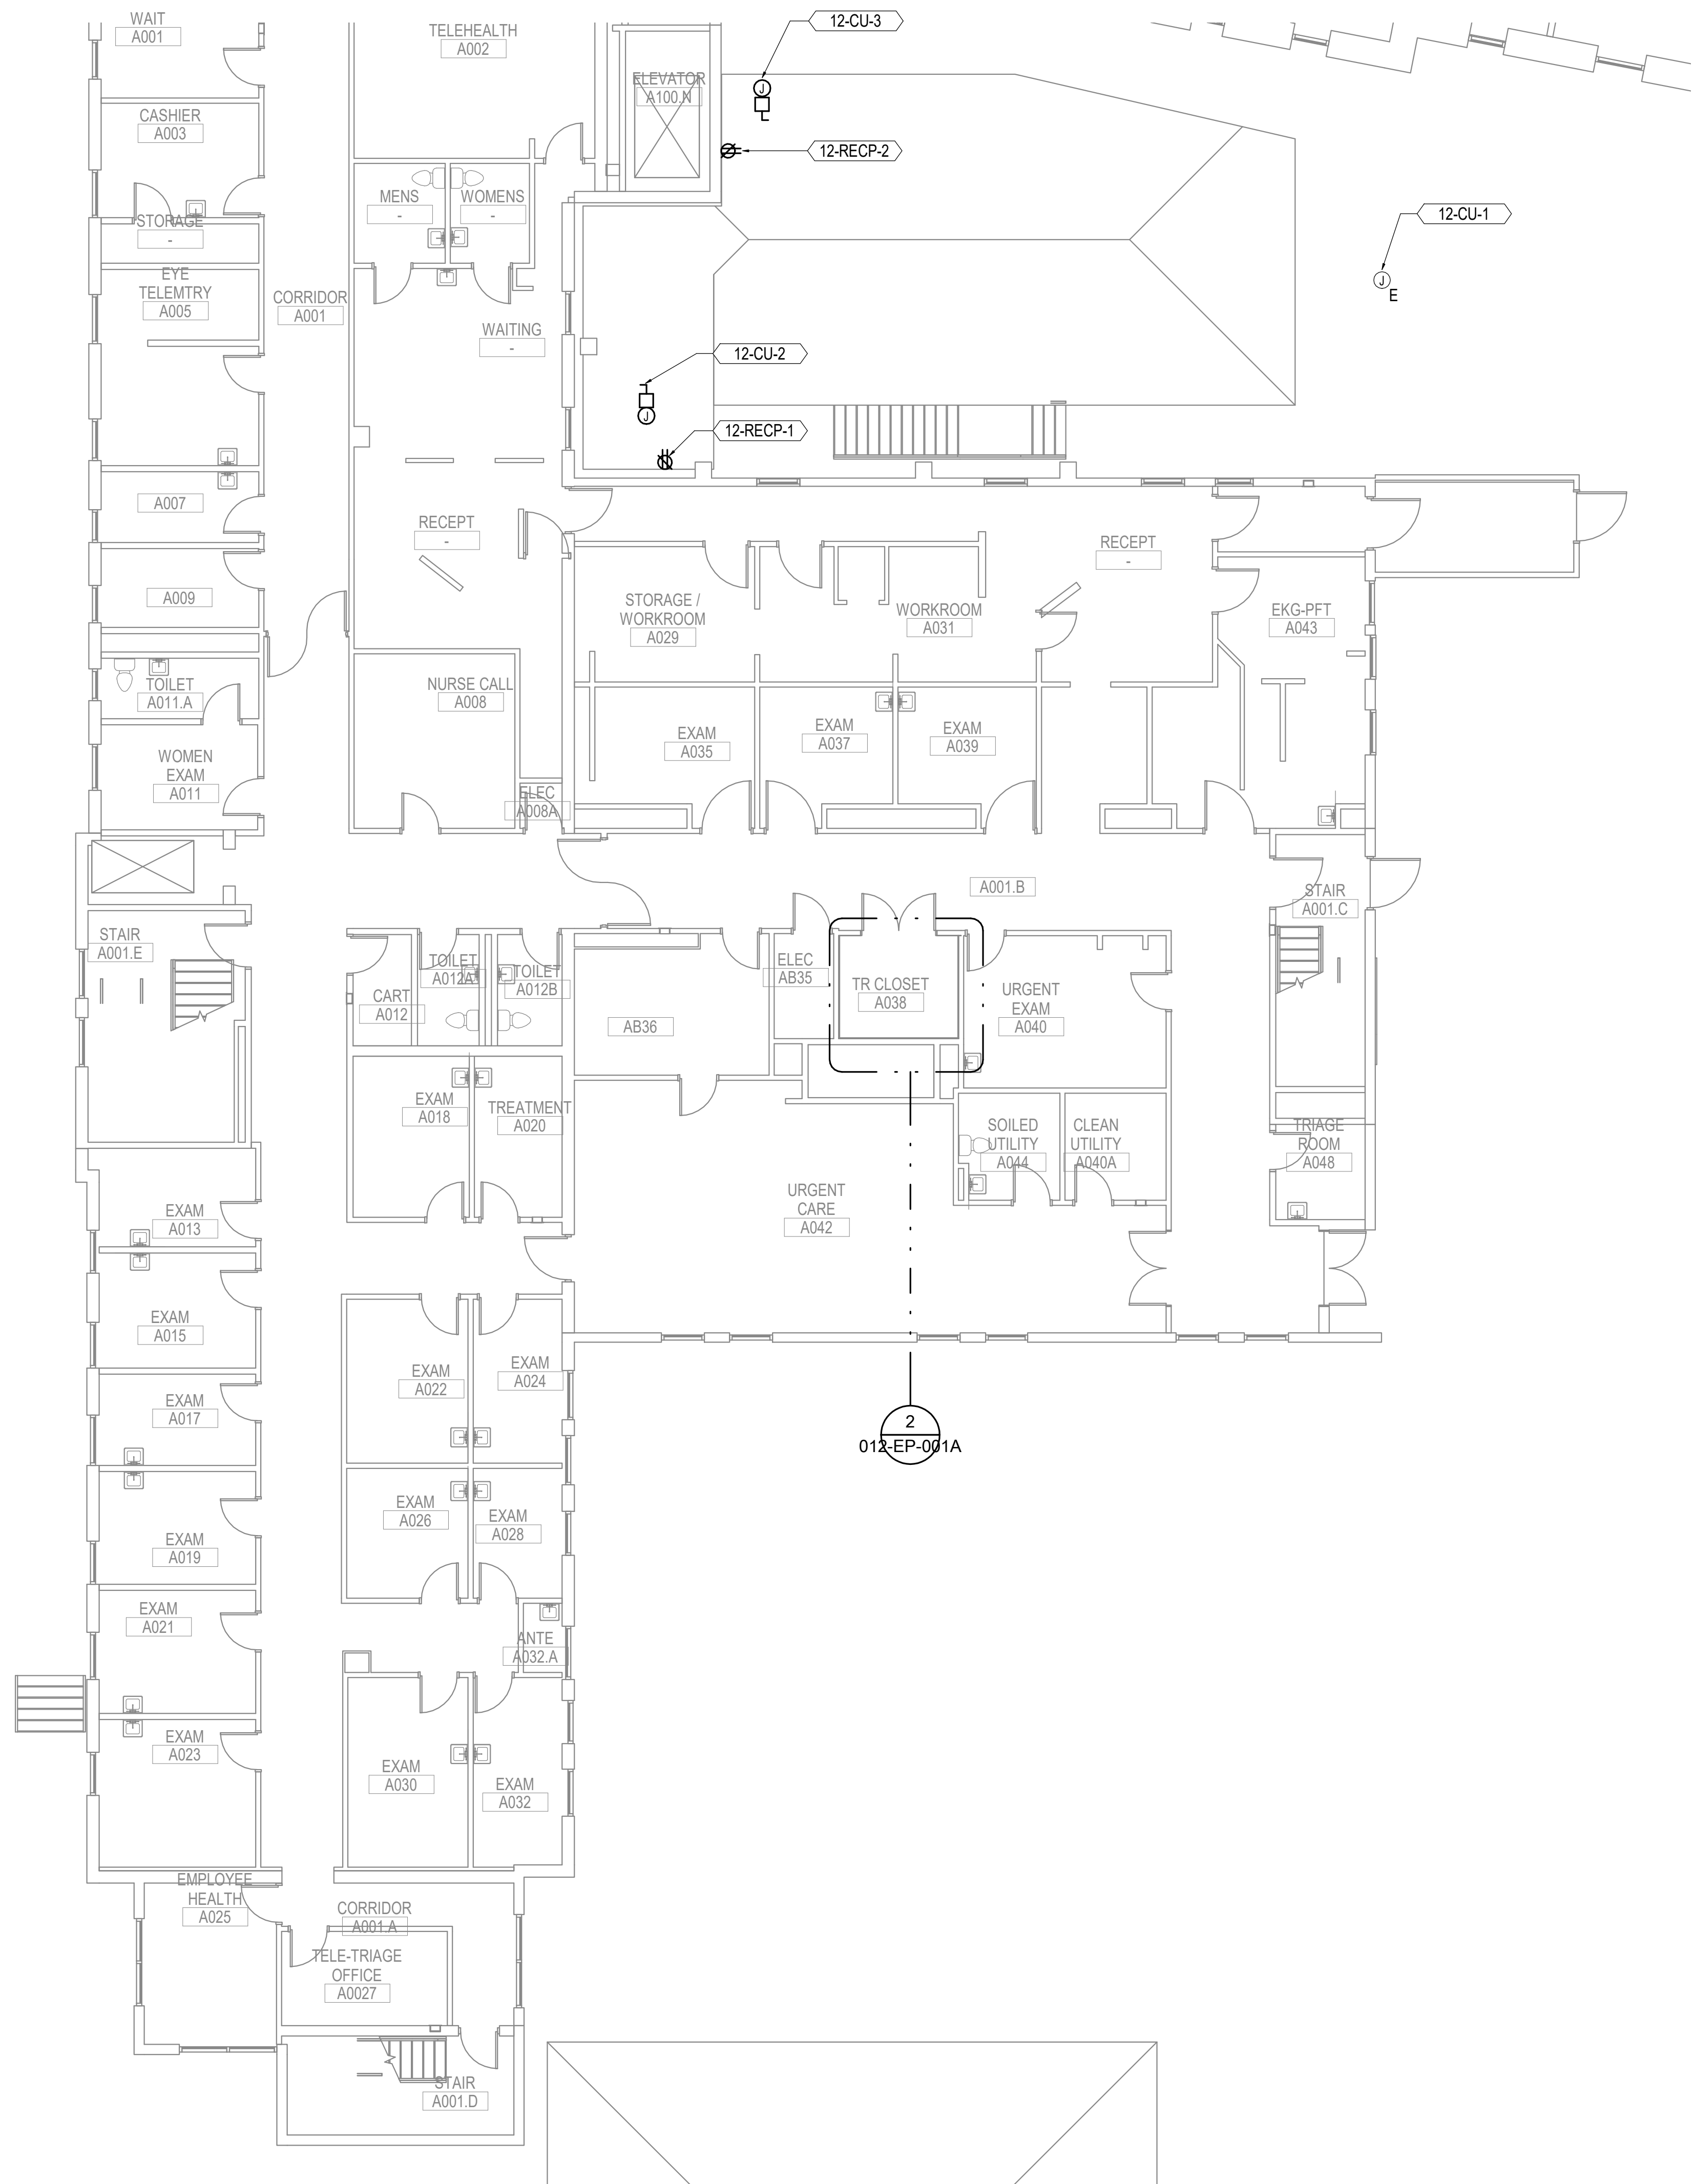


GENERAL NOTES:


A. SEE 012-EP-001 FOR GENERAL NOTES.

SHEET NOTES:


1. PROVIDE RACEWAY AND BOXES FOR ACCESS CONTROLS SYSTEM COMPONENTS. SEE EK-104 FOR TYPICAL DOOR DETAIL.

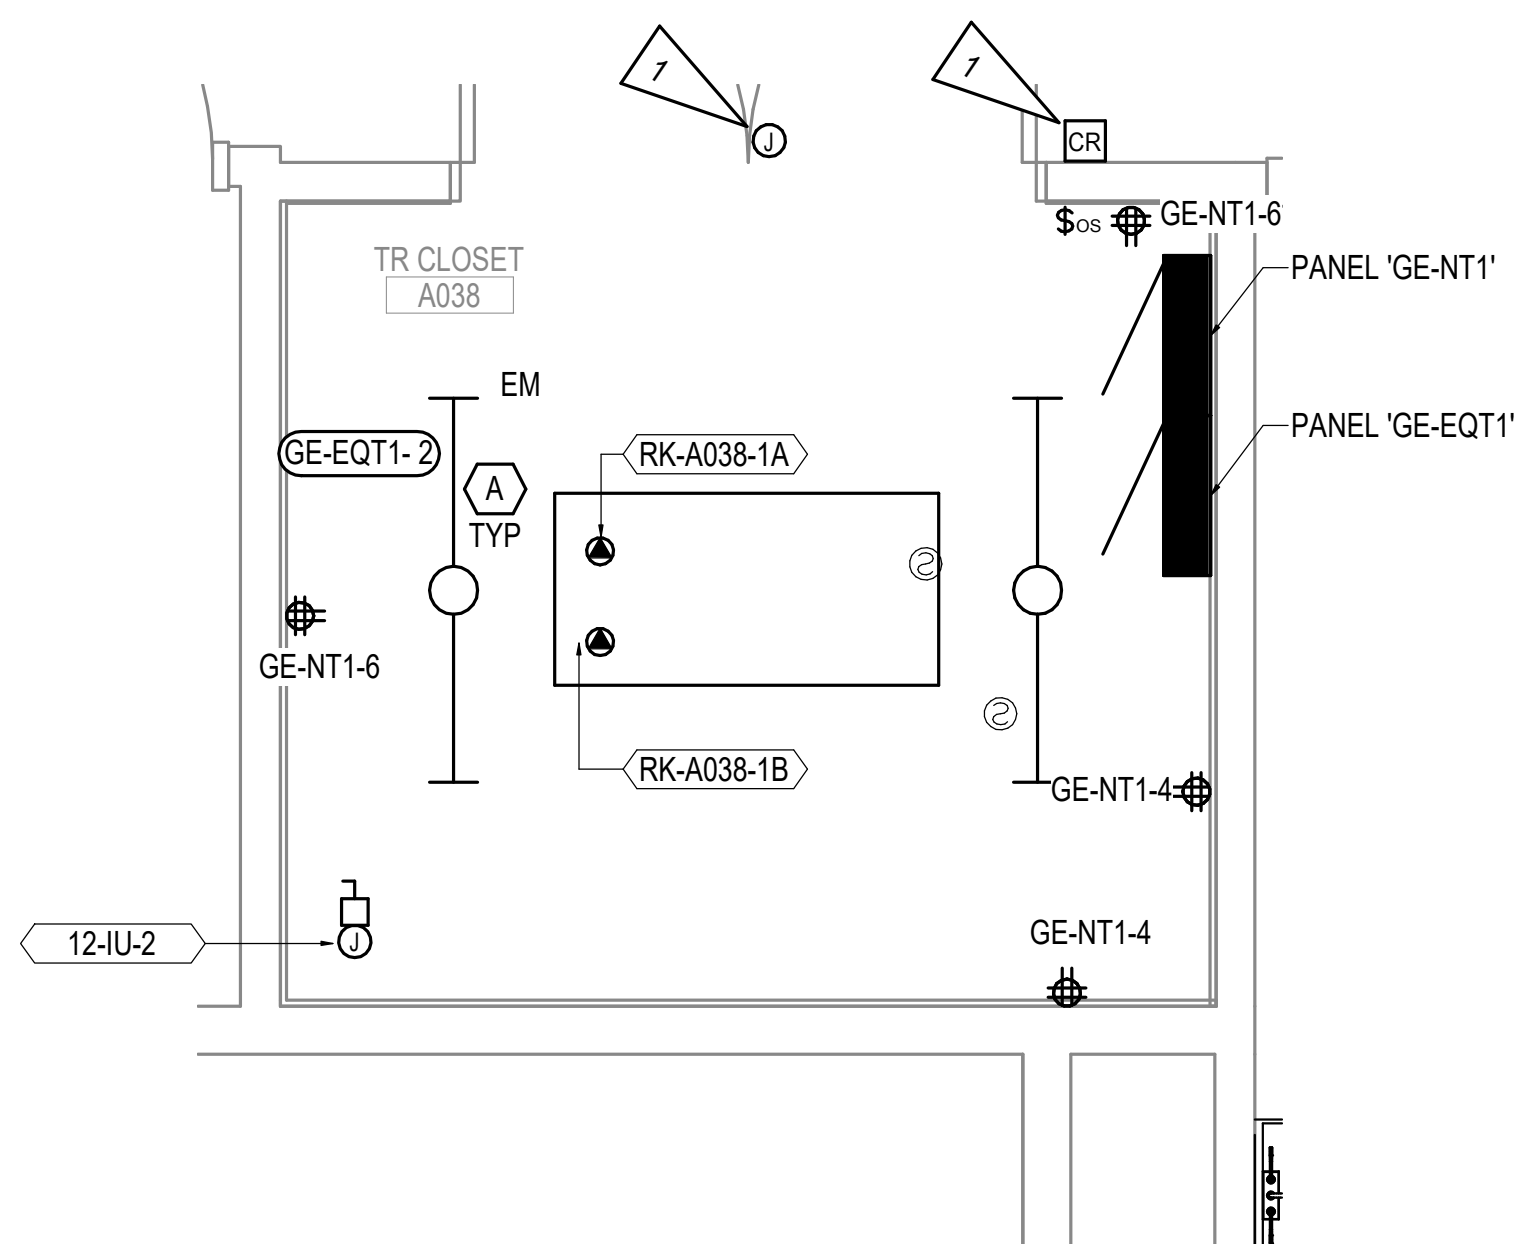

SITE LEGEND

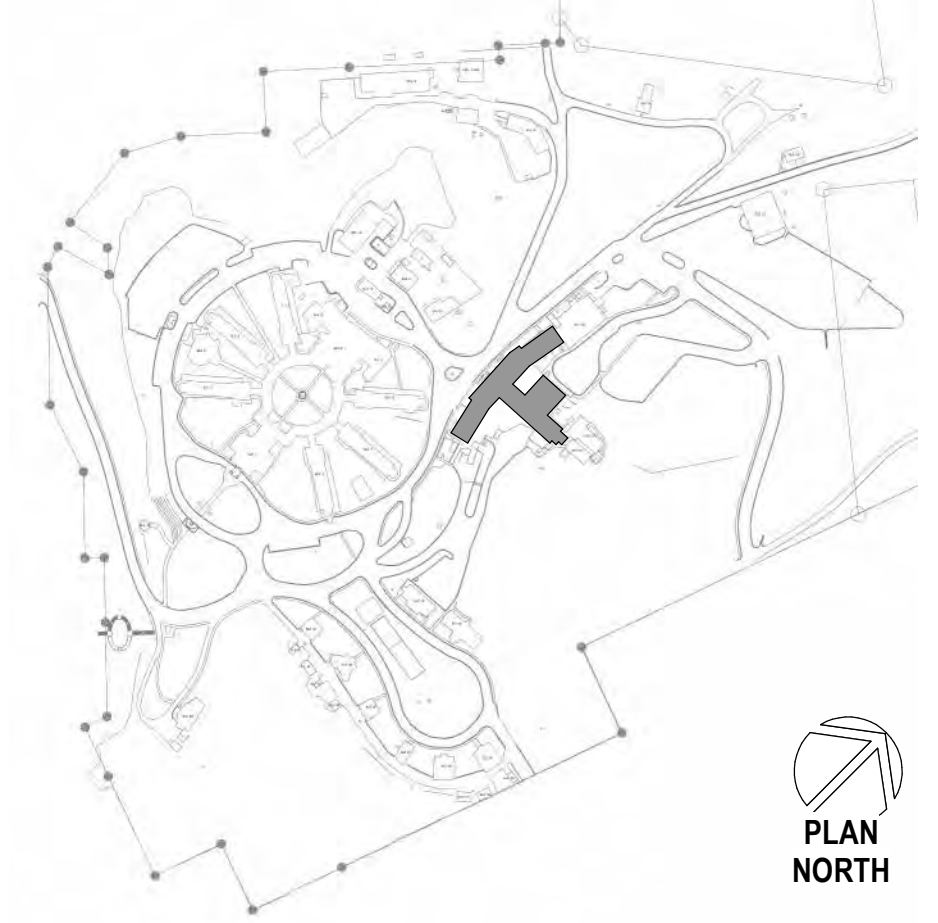

1 ELECTRICAL REMODEL PLAN - BLDG 12 GROUND FLOOR SECTOR A
1/8" = 1'-0"

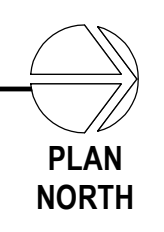

2 ENLARGED ROOM - A038 ELECTRICAL REMODEL
1/2" = 1'-0"



Revisions:	Date:

CONSULTANT

A/E:
GDM
1000 W STEUBEN ST. UNIT 3
BINGEN, WA 98605
541.436.4723
ADAM GOODWIN, PE

GDM
ARCHITECTS • ENGINEERS

ARCHITECT/ENGINEER OF RECORD

RSA
Engineering, Inc.
MECHANICAL AND ELECTRICAL CONSULTING ENGINEERS
670 West Firwood Lane, Suite 200
Anchorage, AK 99503
Phone (907) 278-0521
Corporate No.: AEC542

STAMP

STATE OF ALASKA
JEREMY A. MAXIE
REGISTERED PROFESSIONAL ENGINEER
No. 113847
EXPIRATION DATE 12/31/2025

PROGRAM CONTRACTING ACTIVITY CENTRAL (PCAC)

U.S. Department of Veterans Affairs

DRAWING TITLE

ELECTRICAL REMOD - BLDG 12 GROUND FLOOR A ENLARGED

APPROVED: Project Director

PHASE

100% CD FINAL SOLUTION

FLS

FULLY SPRINKLERED

PROJECT TITLE

EHRM INFRASTRUCTURE UPGRADES

LOCATION

HOT SPRINGS, SOUTH DAKOTA

ISSUE DATE

2/22/2022

CHECKED BY

JAM

DRAWN BY

CSZ

PROJECT NUMBER


568A4-21-702

BUILDING NUMBER

12

DRAWING NUMBER

012-EP-001A

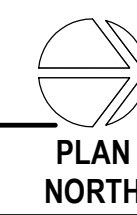

VA FORM 08-6231

PROJECT NUMBER 568A4-21-702
BUILDING NUMBER 12
DRAWING NUMBER 012-EP-001B

A

B

C

D

E

F

A


B

C



D

E

F

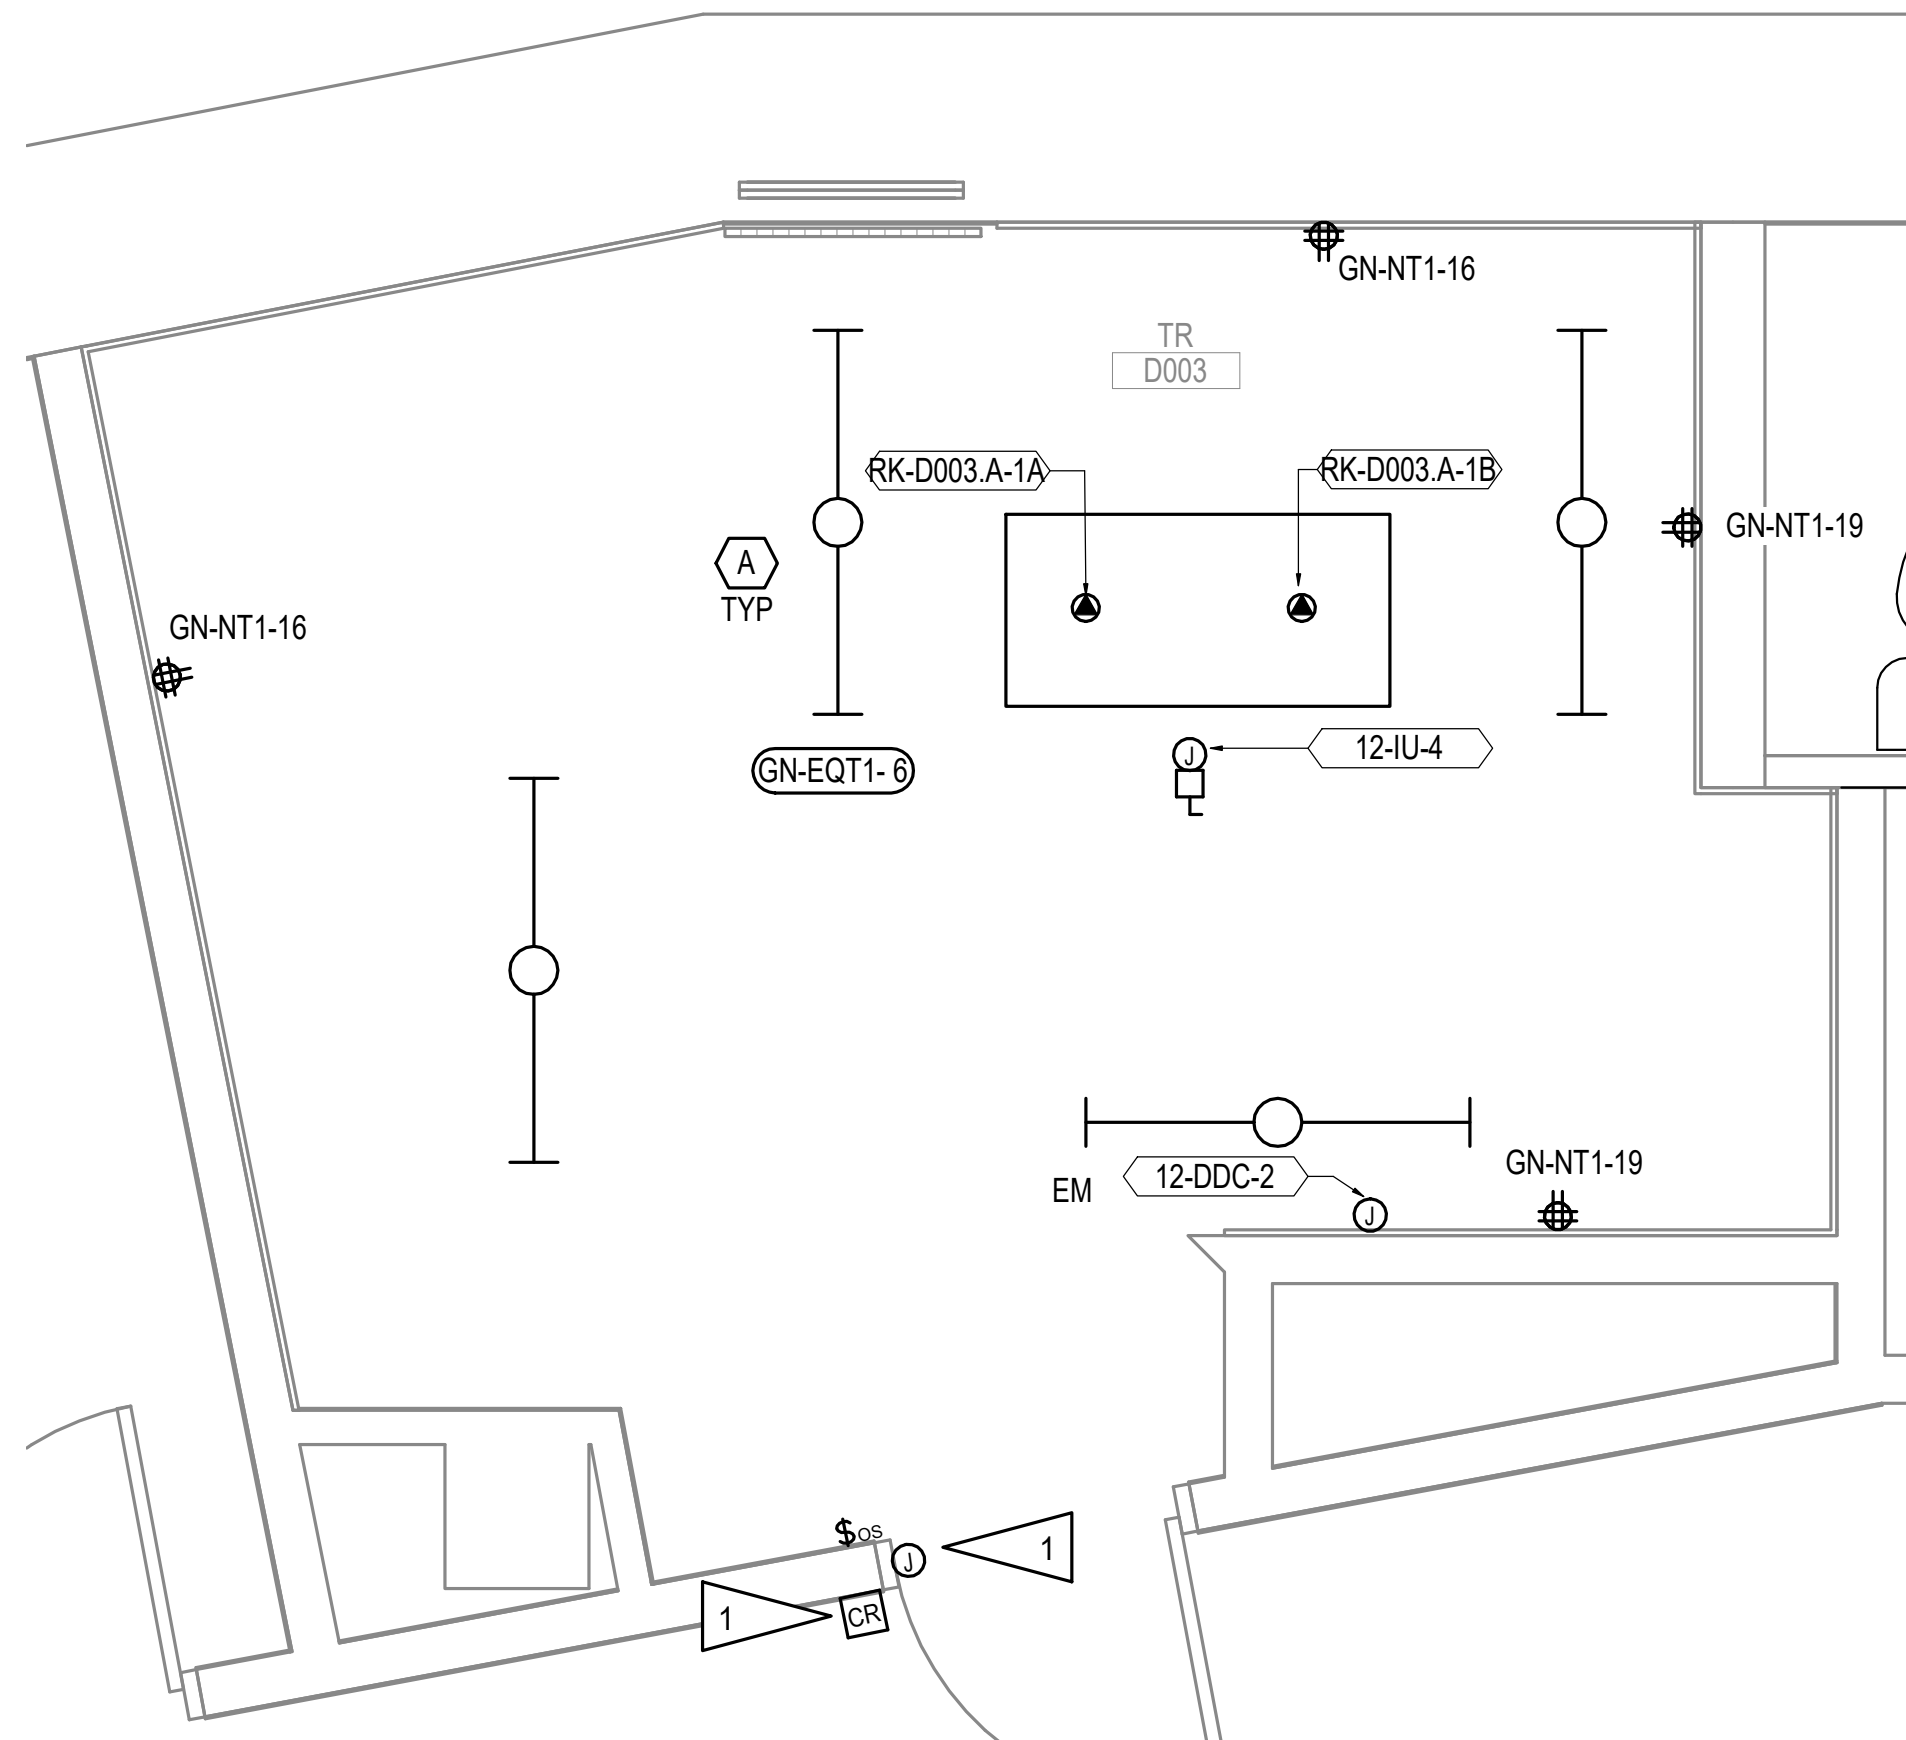

2 ENLARGED ROOM - D003.A ELECTRICAL REMODEL
1/2" = 1'-0"

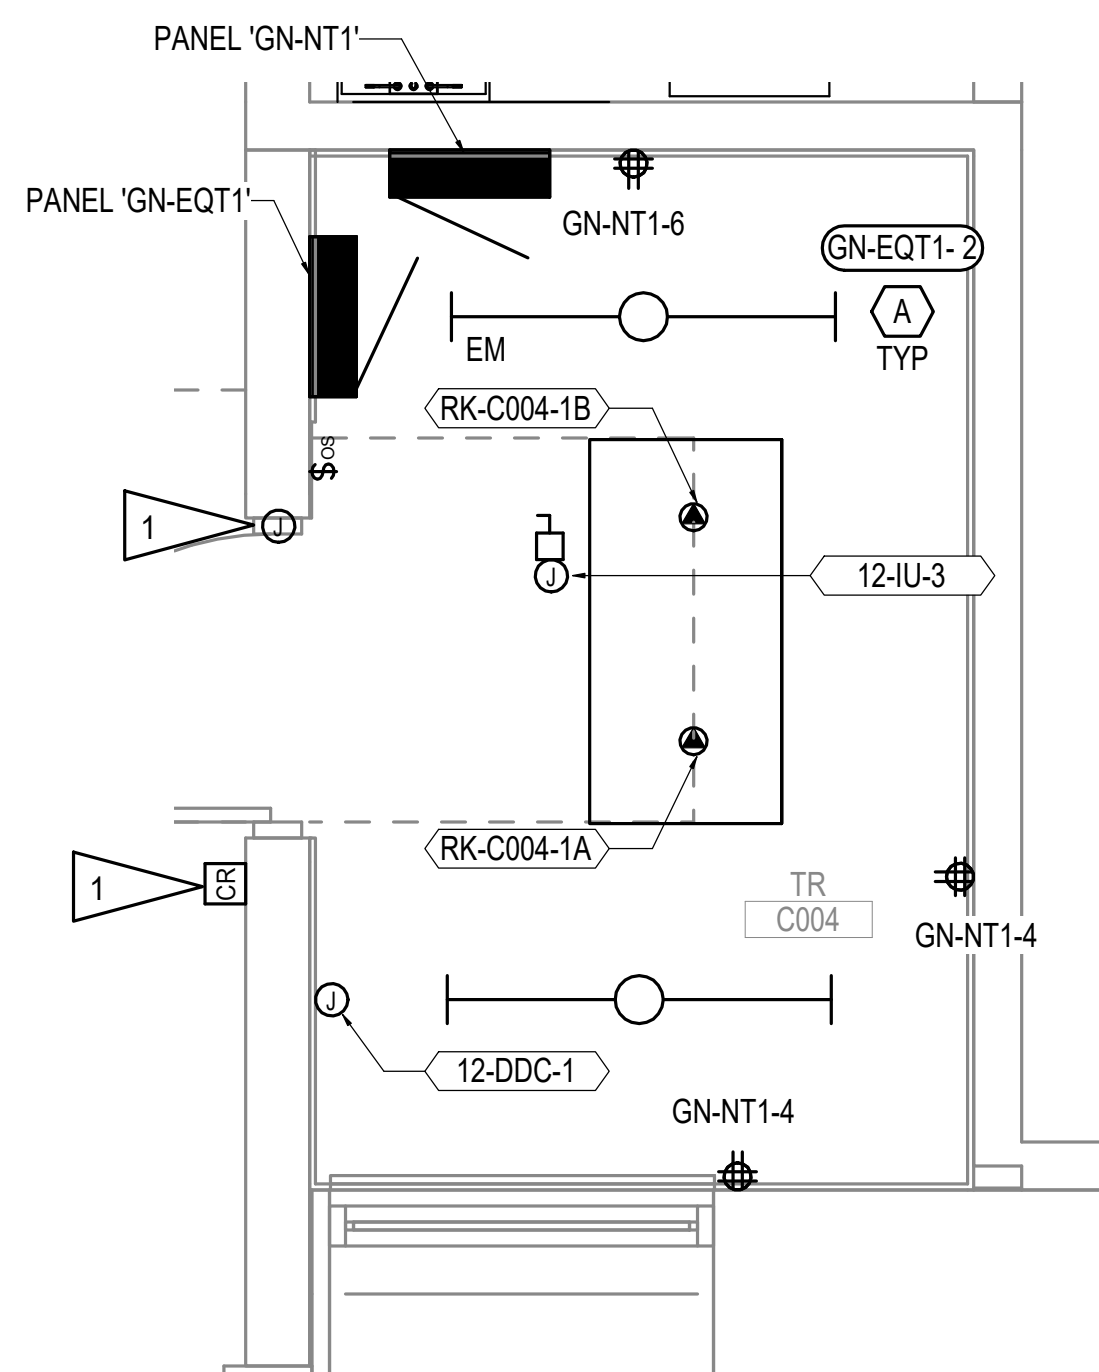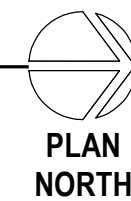

3 ENLARGED ROOM - C004 ELECTRICAL REMODEL
1/2" = 1'-0"




GENERAL NOTES:


A. SEE 012-EP-001 FOR GENERAL NOTES.

SHEET NOTES:


1. PROVIDE RACEWAY AND BOXES FOR ACCESS CONTROLS SYSTEM COMPONENTS. SEE EK-104 FOR TYPICAL DOOR DETAIL.

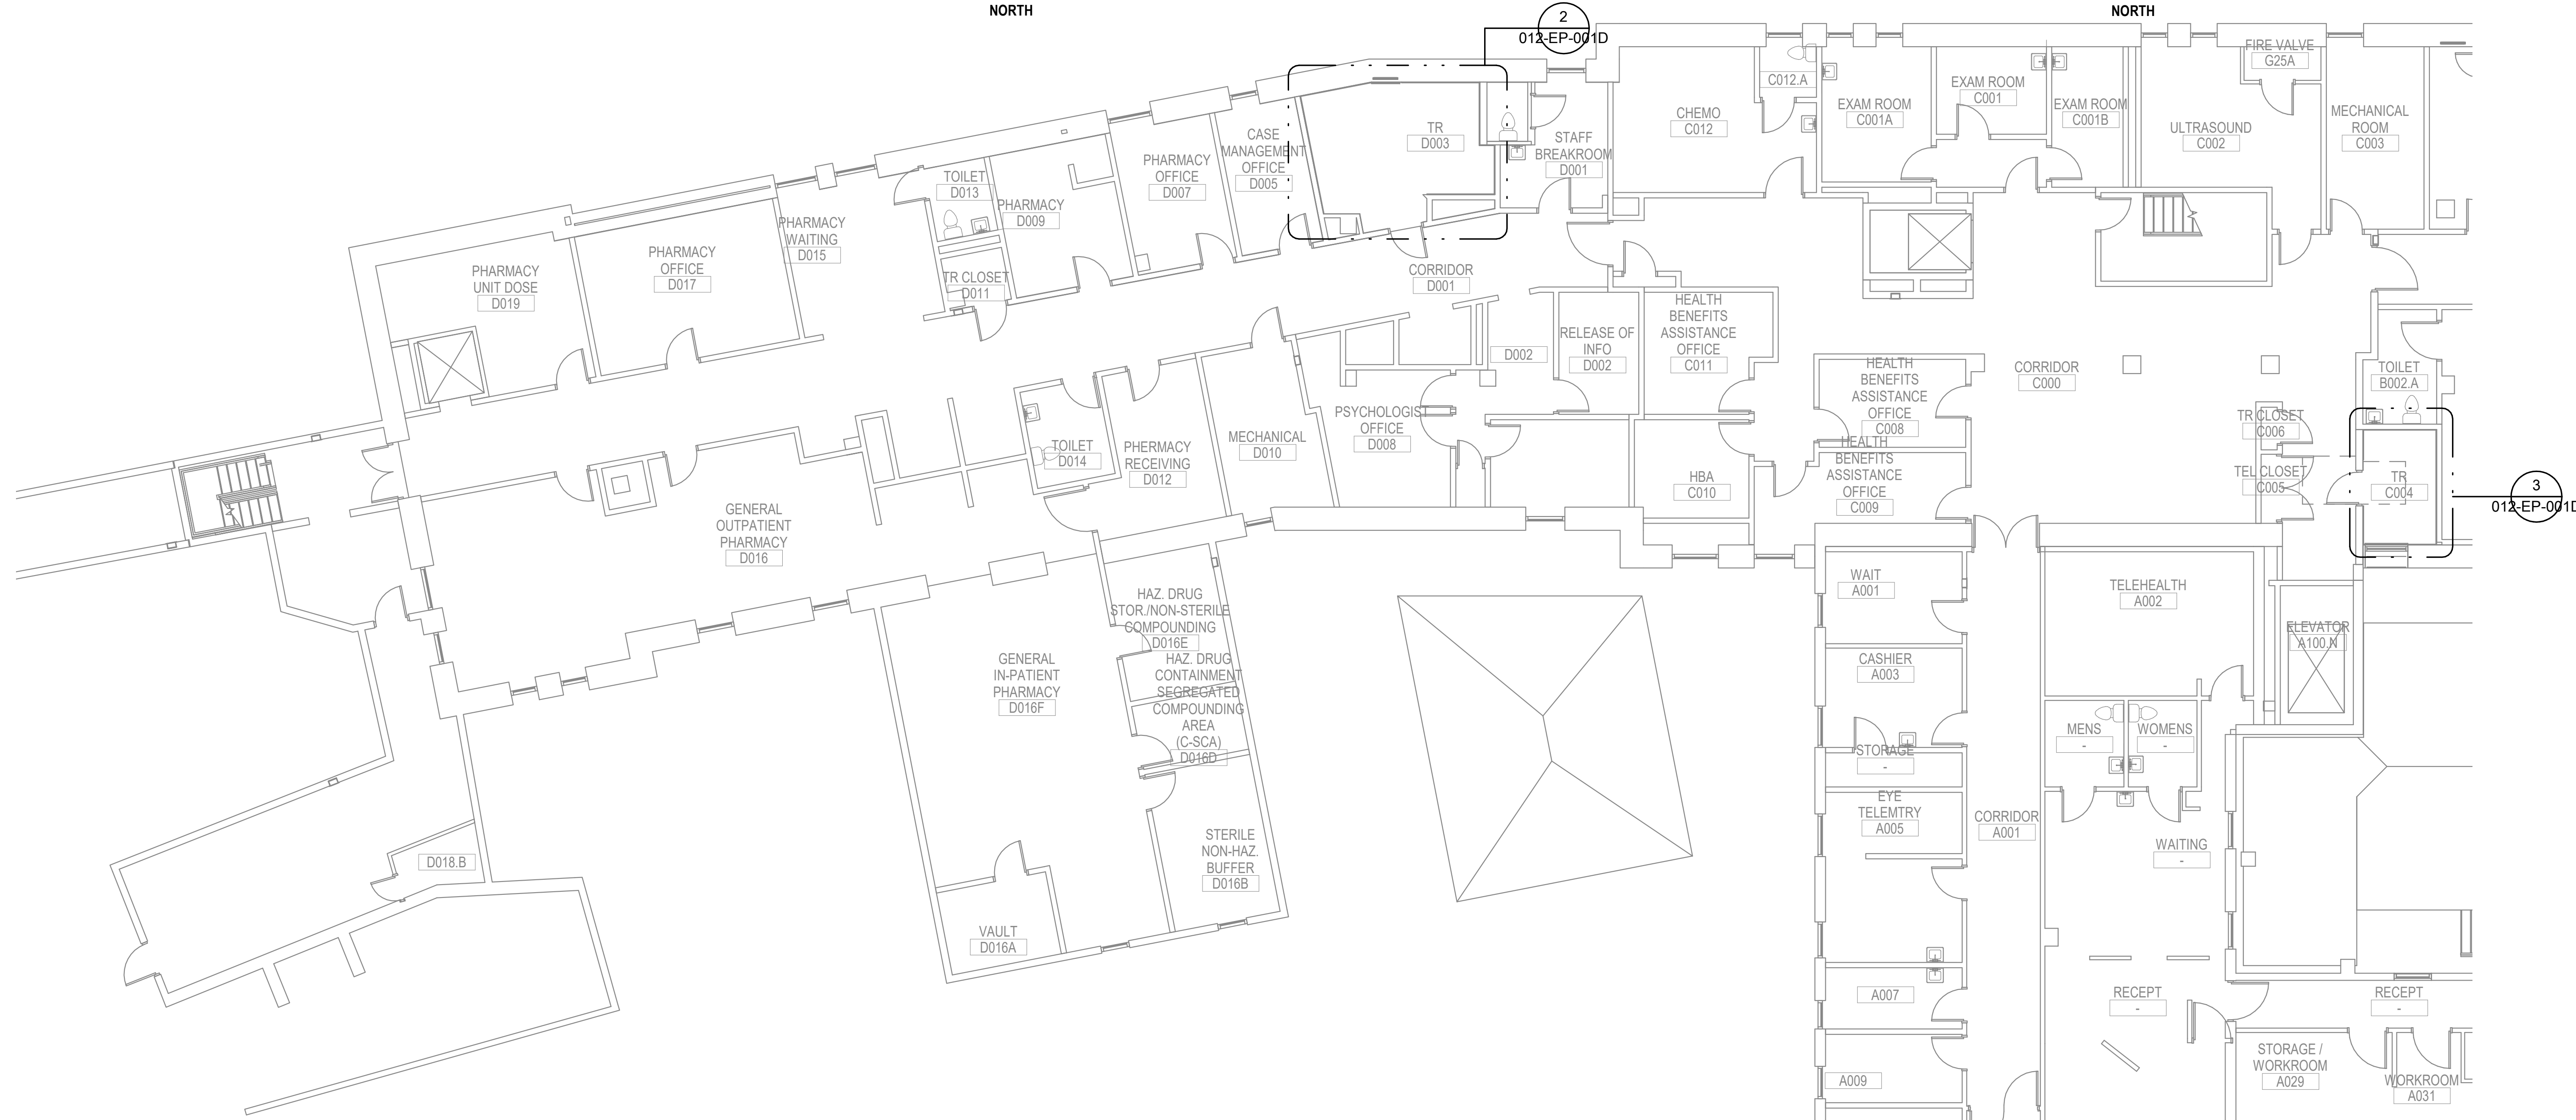

1 ELECTRICAL REMODEL PLAN - BLDG 12 GROUND FLOOR SECTOR C AND D
1/8" = 1'-0"

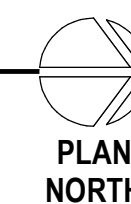

SITE LEGEND

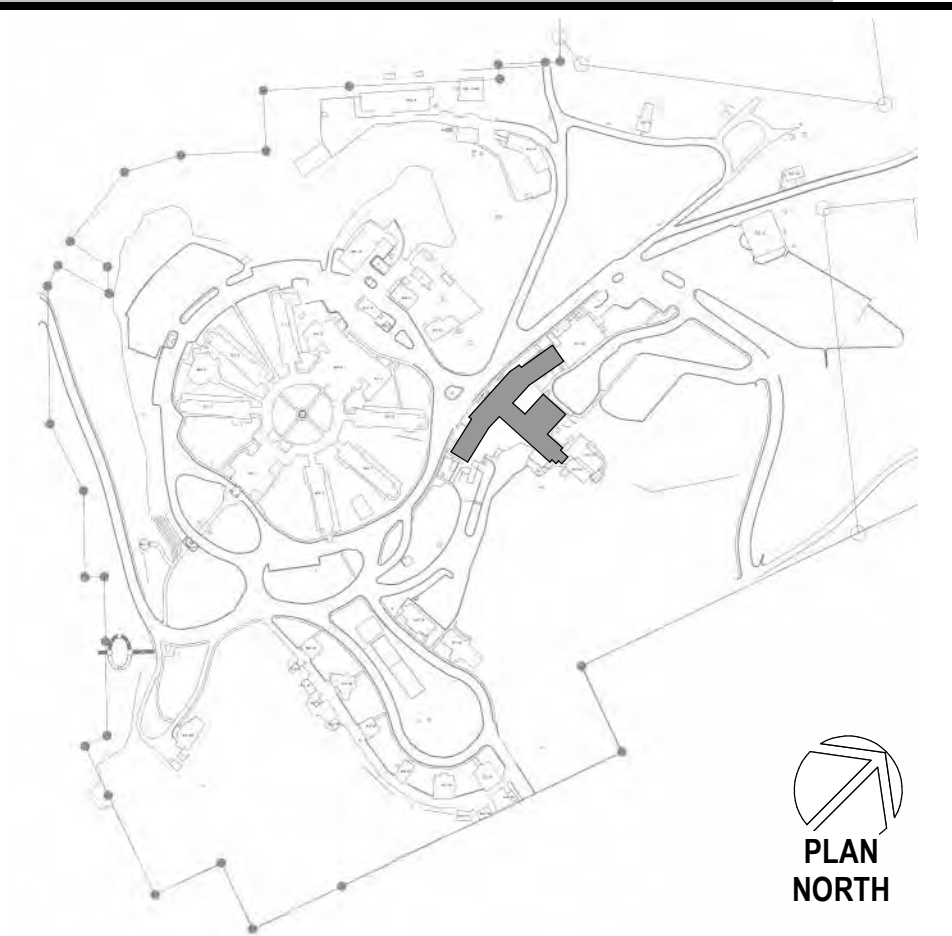

Revisions:	Date:

CONSULTANT

A/E:
GDM
1000 W STEUBEN ST. UNIT 3
BINGEN, WA 98605
541.436.4723
ADAM GOODWIN, PE

GDM
ARCHITECTS • ENGINEERS

ARCHITECT/ENGINEER OF RECORD

RSA
Engineering, Inc.
MECHANICAL AND ELECTRICAL CONSULTING ENGINEERS
670 West Firwood Lane, Suite 200
Anchorage, AK 99503
Phone (907) 278-0521
Corporate No.: AEC542

STAMP

STATE OF ALASKA
JEREMY A. MAXIE
REGISTERED PROFESSIONAL ENGINEER
No. 113847
EXPIRES 12/31/2025

PROGRAM CONTRACTING ACTIVITY CENTRAL (PCAC)

VA U.S. Department of Veterans Affairs

DRAWING TITLE
ELECTRICAL REMOD - BLDG 12 GROUND FLOOR C/D ENLARGED

APPROVED: Project Director

PHASE
100% CD FINAL SOLUTION

FLS
FULLY SPRINKLERED

PROJECT TITLE
EHRM INFRASTRUCTURE UPGRADES

LOCATION
HOT SPRINGS, SOUTH DAKOTA

ISSUE DATE
2/22/2022


CHECKED BY
JAM

DRAWN BY
CSZ

PROJECT NUMBER
568A4-21-702

BUILDING NUMBER
12

DRAWING NUMBER
012-EP-001D

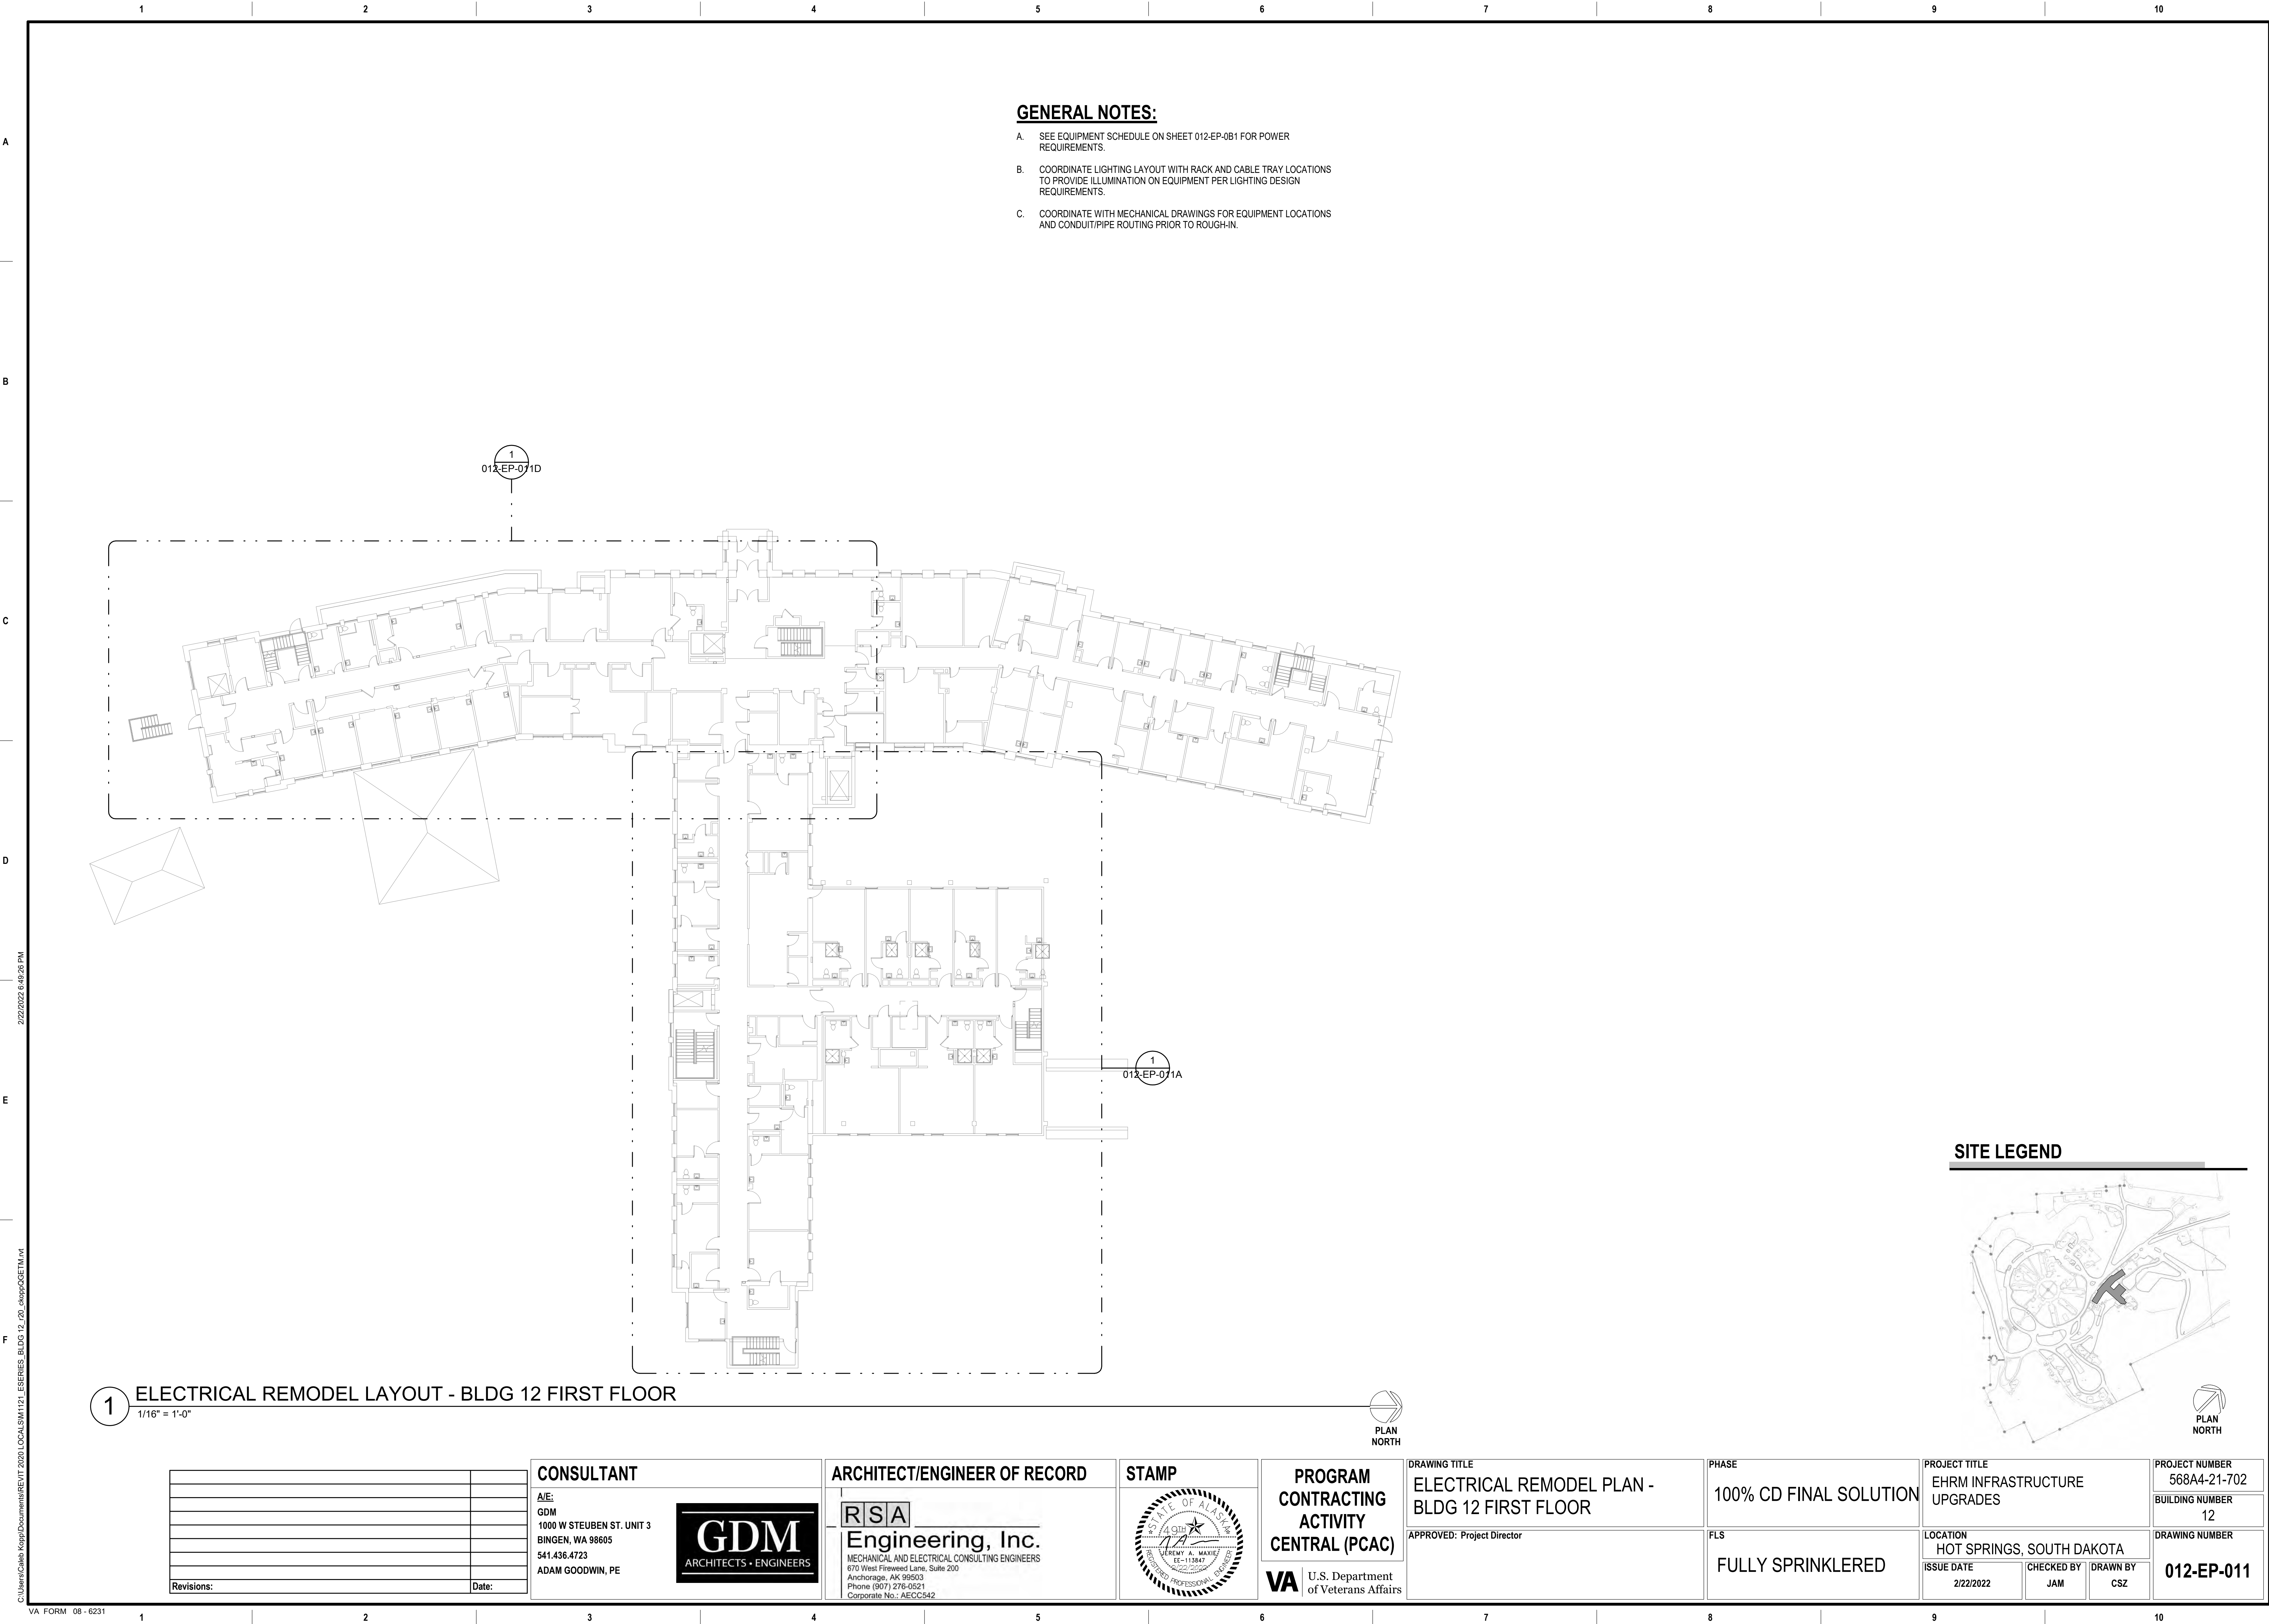


GENERAL NOTES:


A. SEE 012-EP-011 FOR GENERAL NOTES.

SHEET NOTES:

1. PROVIDE RACEWAY AND BOXES FOR ACCESS CONTROLS SYSTEM COMPONENTS. SEE EK-104 FOR TYPICAL DOOR DETAIL.

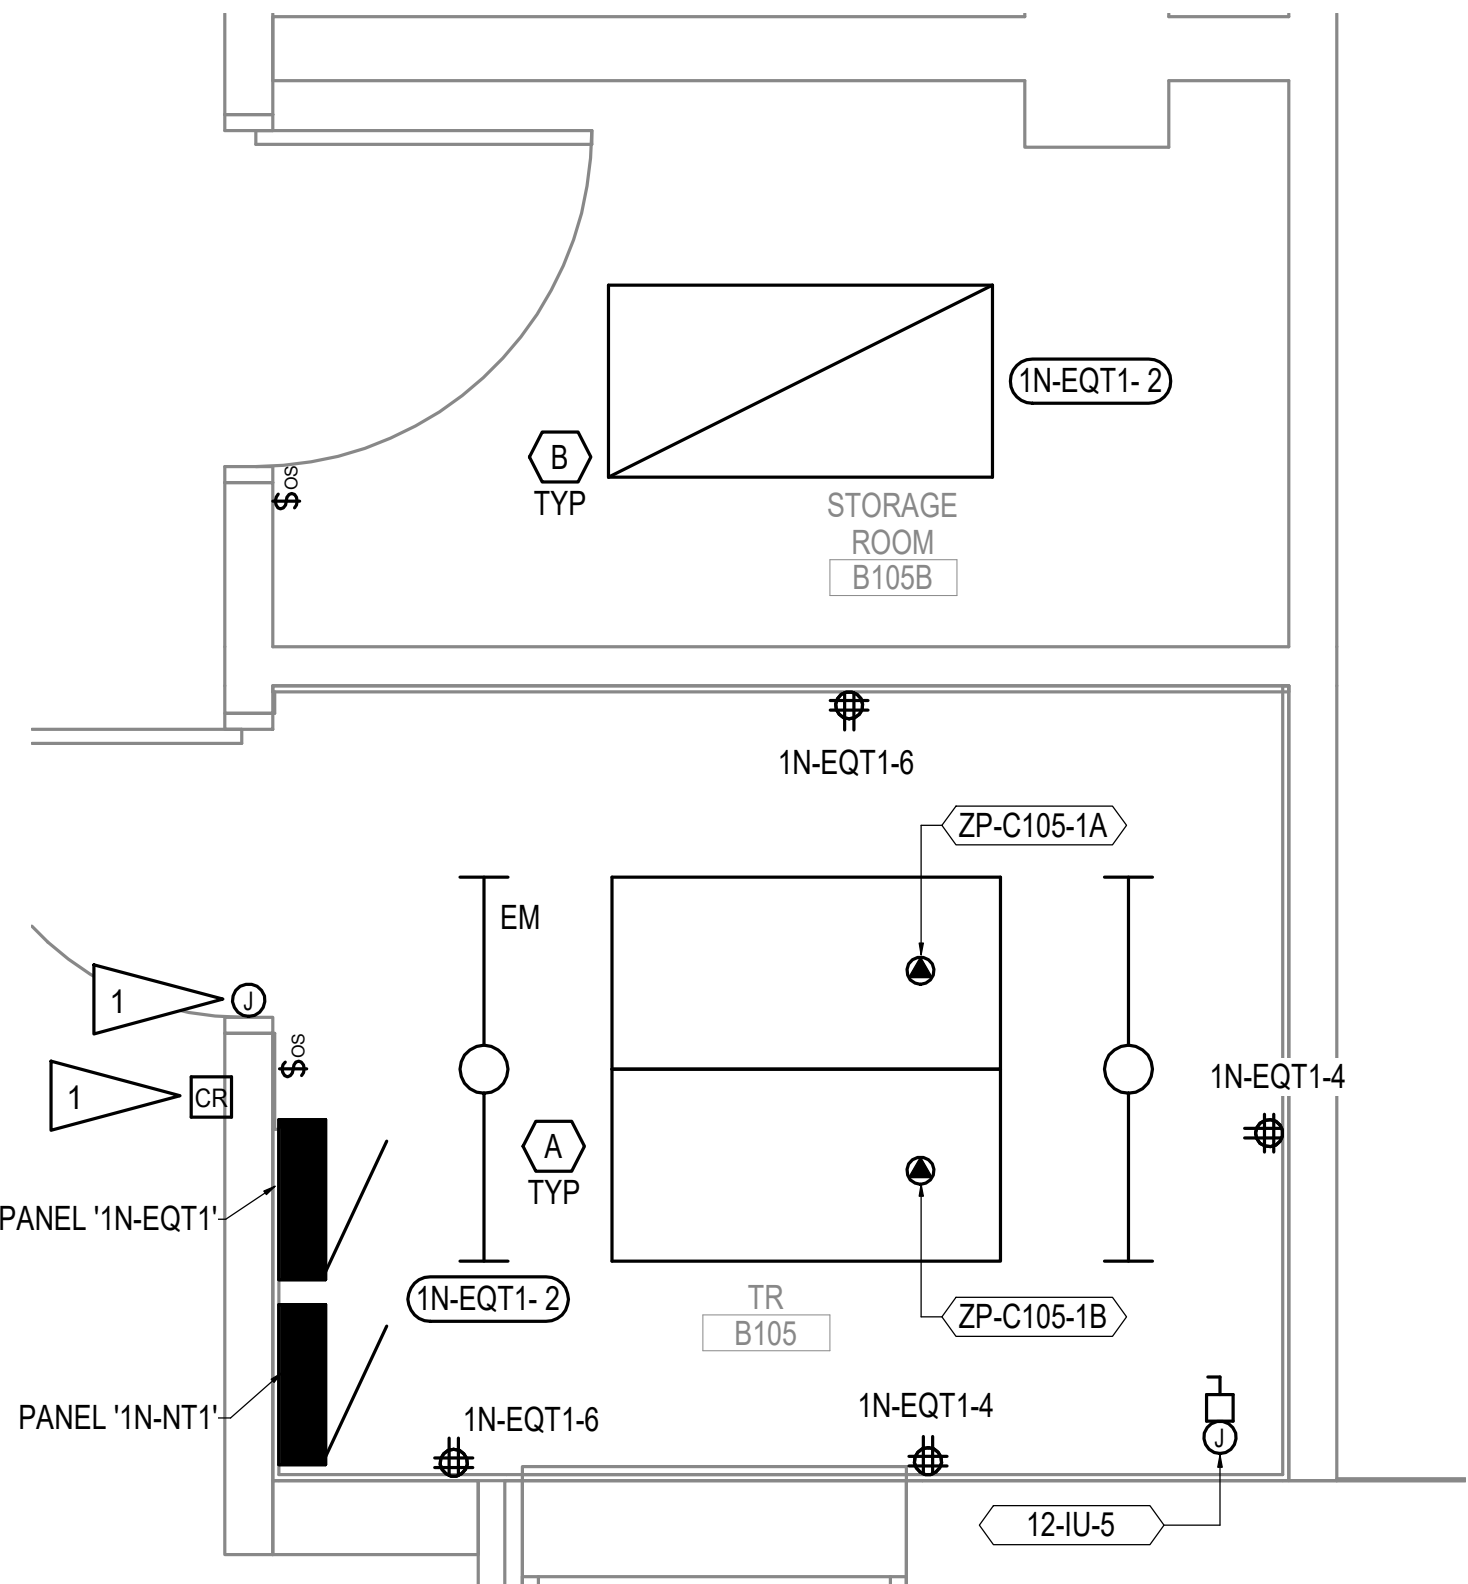


2 ENLARGED ROOM - C106D ELECTRICAL REMODEL
1/2" = 1'-0"

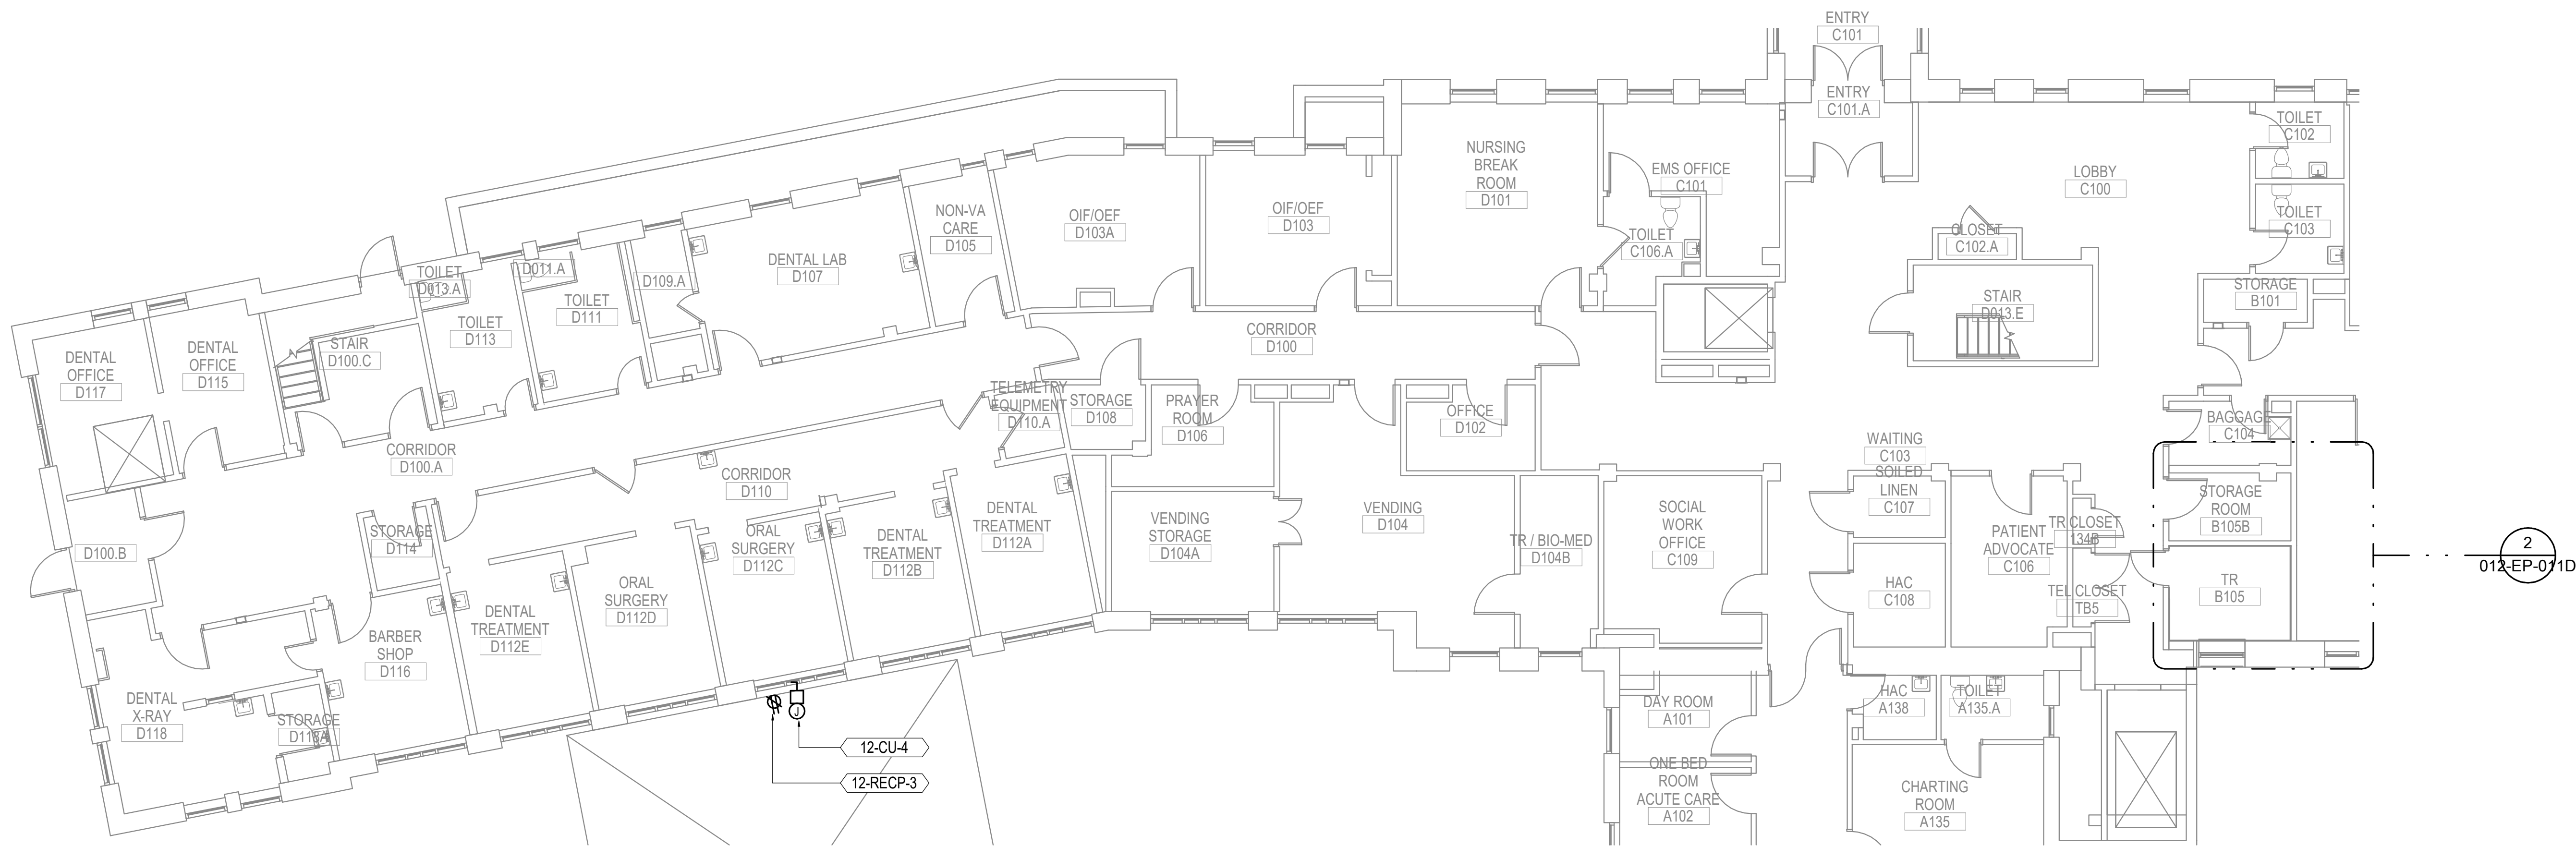

1 ELECTRICAL REMODEL PLAN - BLDG 12 FIRST FLOOR SECTOR C AND D
1/8" = 1'-0"



SITE LEGEND

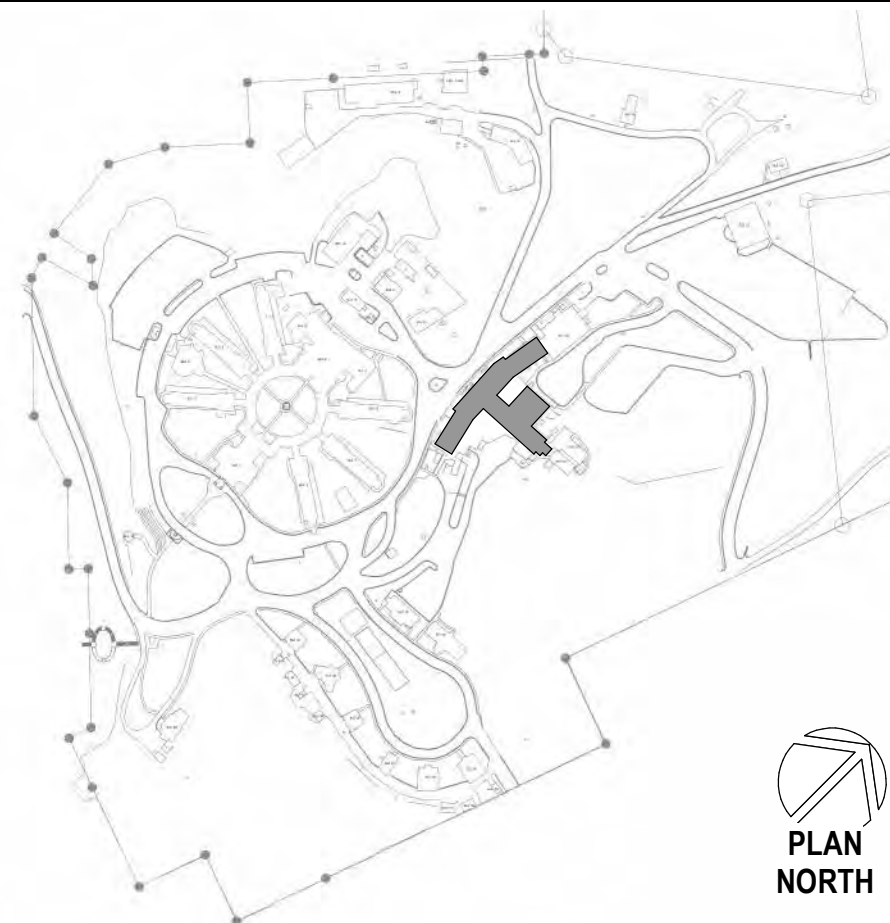

Revisions:	Date:

CONSULTANT

A/E:
GDM
1000 W STEUBEN ST. UNIT 3
BINGEN, WA 98605
541.436.4723
ADAM GOODWIN, PE

GDM
ARCHITECTS • ENGINEERS

ARCHITECT/ENGINEER OF RECORD

RSA
Engineering, Inc.
MECHANICAL AND ELECTRICAL CONSULTING ENGINEERS
670 West Firwood Lane, Suite 200
Anchorage, AK 99503
Phone (907) 278-0521
Corporate No.: AEC0542

STAMP

STATE OF ALASKA
JEREMY A. MAXIE
1E-113847
REGISTERED PROFESSIONAL ENGINEER

PROGRAM CONTRACTING ACTIVITY CENTRAL (PCAC)

VA U.S. Department of Veterans Affairs

DRAWING TITLE
ELECTRICAL REMOD - BLDG 12
FIRST FLOOR C/D ENLARGED

APPROVED: Project Director

PHASE
100% CD FINAL SOLUTION

FLS
FULLY SPRINKLERED

PROJECT TITLE
EHRM INFRASTRUCTURE UPGRADES

LOCATION
HOT SPRINGS, SOUTH DAKOTA

ISSUE DATE
2/22/2022

CHECKED BY
JAM

DRAWN BY
CSZ

PROJECT NUMBER
568A4-21-702


BUILDING NUMBER
12

DRAWING NUMBER
012-EP-011D


C:\Users\Calab\AppData\Local\Microsoft\OneDrive\OneDrive\Documents\REVIT 2020\LOCALS\1121\ESERIES_BLDG 12_200_000\02EP10.dwg 2/22/2022 8:49:32 PM

GENERAL NOTES:

- A. SEE EQUIPMENT SCHEDULE ON SHEET 012-EP-0B1 FOR POWER REQUIREMENTS.
- B. COORDINATE LIGHTING LAYOUT WITH RACK AND CABLE TRAY LOCATIONS TO PROVIDE ILLUMINATION ON EQUIPMENT PER LIGHTING DESIGN REQUIREMENTS.
- C. COORDINATE WITH MECHANICAL DRAWINGS FOR EQUIPMENT LOCATIONS AND CONDUIT/PIPE ROUTING PRIOR TO ROUGH-IN.

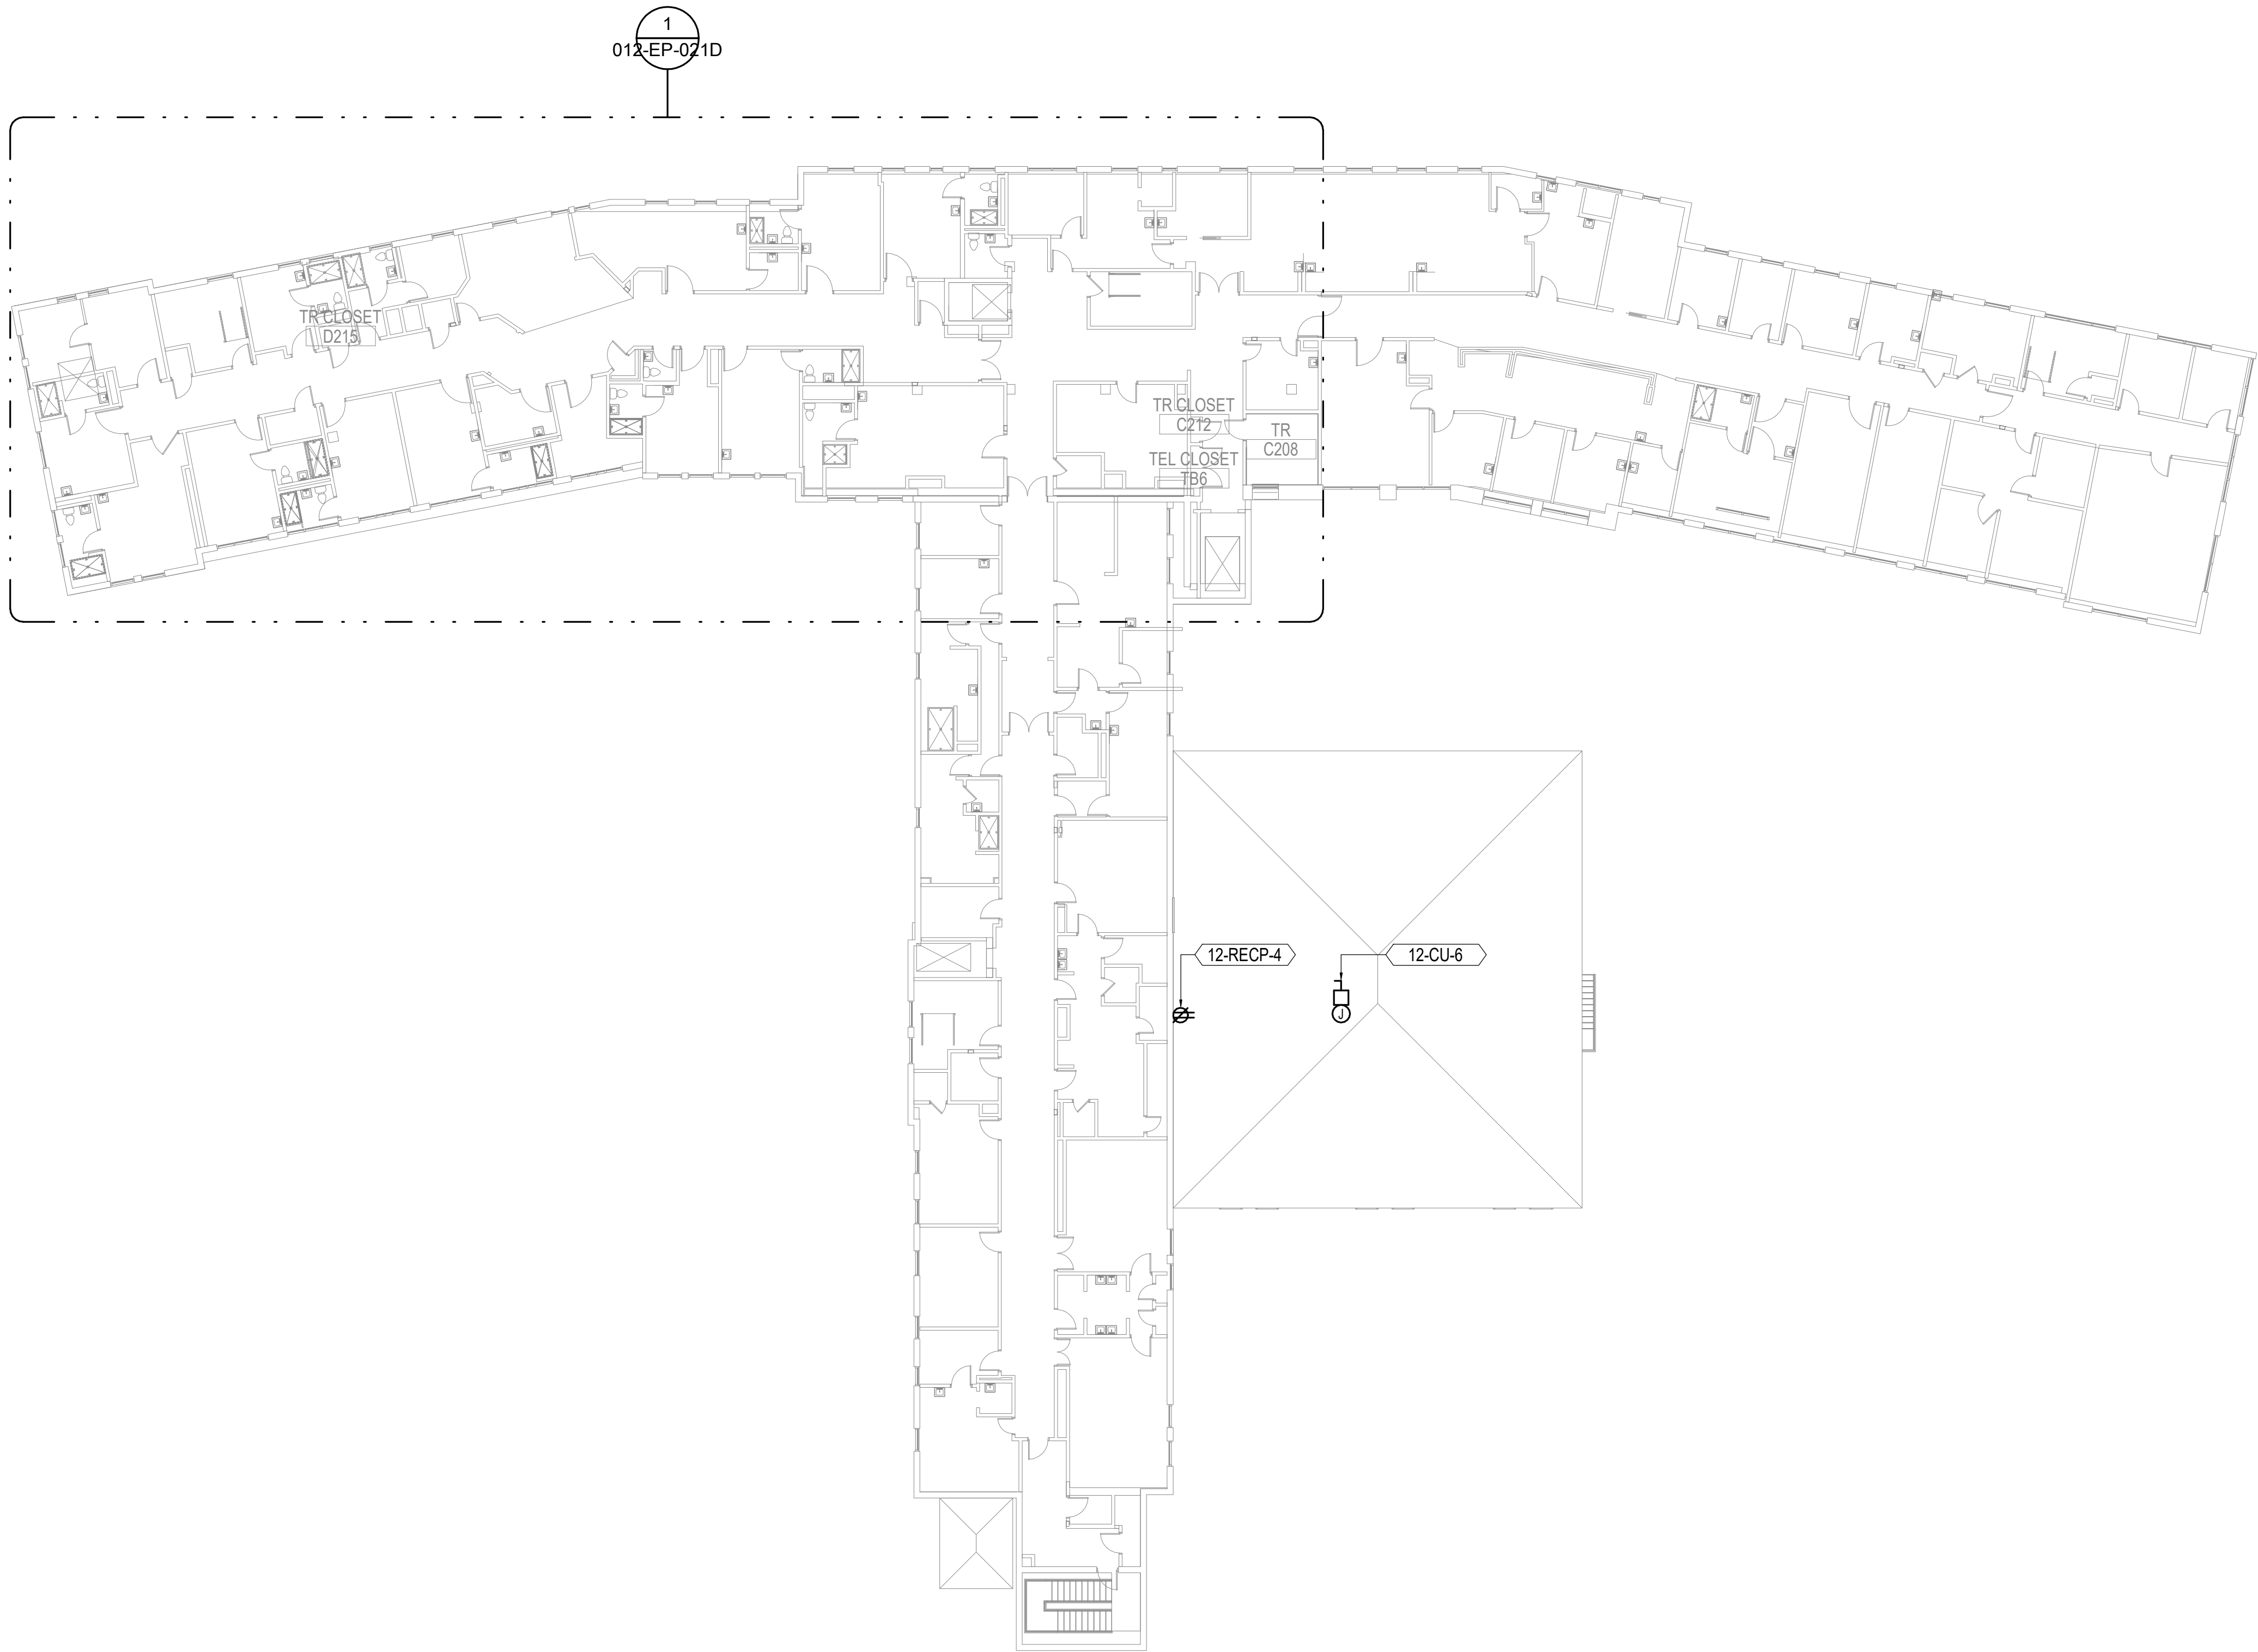

SITE LEGEND

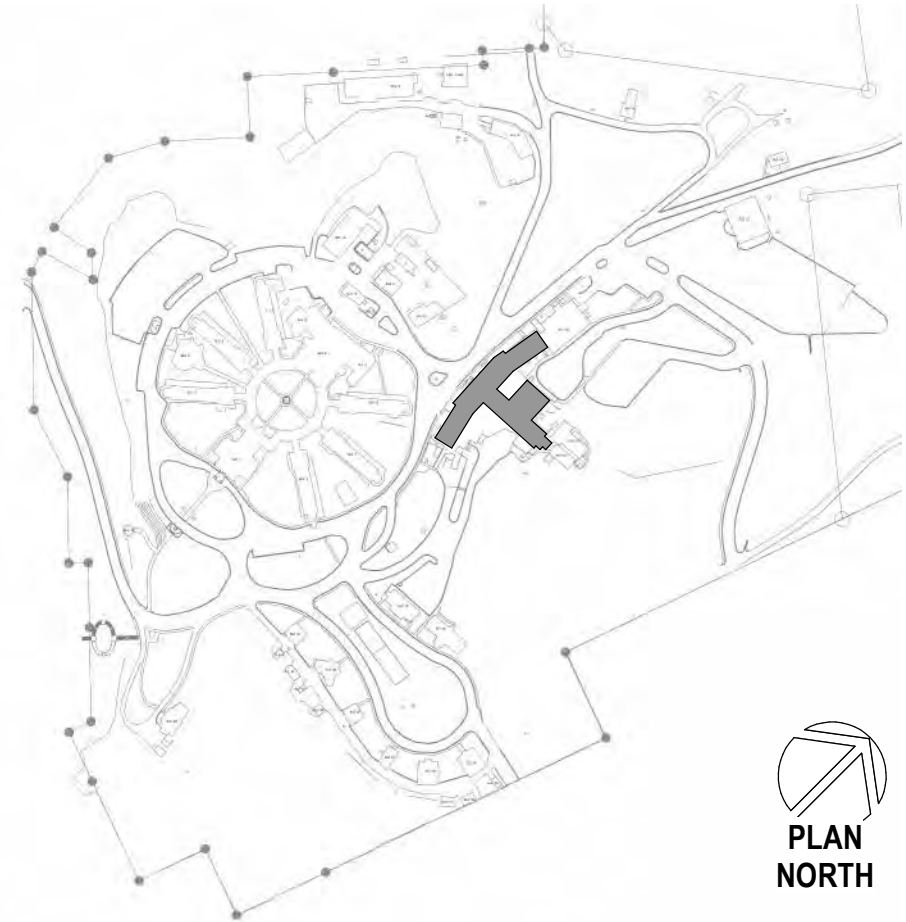

1 ELECTRICAL REMODEL LAYOUT - BLDG 12 SECOND FLOOR
1/16" = 1'-0"



Revisions:	Date:

CONSULTANT

A/E:
GDM
1000 W STEUBEN ST. UNIT 3
BINGEN, WA 98605
541.436.4723
ADAM GOODWIN, PE

ARCHITECT/ENGINEER OF RECORD

MECHANICAL AND ELECTRICAL CONSULTING ENGINEERS
670 West Firwood Lane, Suite 200
Anchorage, AK 99503
Phone (907) 276-0521
Corporate No.: AECC542

STAMP

PROGRAM
CONTRACTING
ACTIVITY
CENTRAL (PCAC)

U.S. Department
of Veterans Affairs

DRAWING TITLE

ELECTRICAL REMODEL PLAN -
BLDG 12 SECOND FLOOR

APPROVED: Project Director

PHASE

100% CD FINAL SOLUTION

FLS

FULLY SPRINKLERED

PROJECT TITLE

EHRM INFRASTRUCTURE
UPGRADES

LOCATION

HOT SPRINGS, SOUTH DAKOTA

ISSUE DATE

2/22/2022

CHECKED BY

JAM

DRAWN BY

CSZ

PROJECT NUMBER

568A4-21-702

BUILDING NUMBER

12

DRAWING NUMBER

012-EP-021

- A. SEE EQUIPMENT SCHEDULE ON SHEET 012-EP-0B1 FOR POWER REQUIREMENTS.
- B. COORDINATE LIGHTING LAYOUT WITH RACK AND CABLE TRAY LOCATIONS TO PROVIDE ILLUMINATION ON EQUIPMENT PER LIGHTING DESIGN REQUIREMENTS.
- C. COORDINATE WITH MECHANICAL DRAWINGS FOR EQUIPMENT LOCATIONS AND CONDUIT/PIPE ROUTING PRIOR TO ROUGH-IN.



PROJECT NUMBER
568A4-21-702


 
BUILDING NUMBER
12

DRAWING NUMBER
012-EP-031


A. SEE 012-EP-031 FOR GENERAL NOTES.

A. SEE 012-EP-031 FOR GENERAL NOTES.

1. PROVIDE RACEWAY AND BOXES FOR ACCESS CONTROLS SYSTEM COMPONENTS. SEE EK-104 FOR TYPICAL DOOR DETAIL.

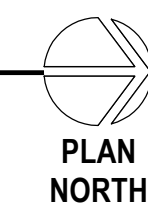

1 ELEC
1/8" = 1'-0"

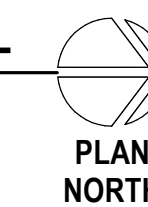

2 ENLA
1/2" = 1'-0"



CONSULTANT

A/E:
GDM
1000 W STEUBEN ST. UNIT 3
BINGEN, WA 98605
541.436.4723
ADAM GOODWIN, PE

STAMP

STATE OF ALASKA
4 QTH
7/19
JEREMY A. MAXIE
EE-113847
12/22/2025
REGISTERED PROFESSIONAL ENGINEER

DRAWING TITLE

ELECTRICAL REMOD - BLDG 12
THIRD FLOOR B ENLARGED

APPROVED: Project Director

PROJECT TITLE		
EHRM INFRASTRUCTURE UPGRADES		
LOCATION		
HOT SPRINGS, SOUTH DAKOTA		
ISSUE DATE	CHECKED BY	DRAWN BY
2/22/2022	JAM	CSZ

PROJECT NUMBER
568A4-21-702
BUILDING NUMBER
12
DRAWING NUMBER
012-EP-031B



EQUIPMENT SCHEDULE - BUILDING 14


ID TAG	EQUIPMENT DESCRIPTION	ELECTRICAL DATA						REQUIRES DISCONNECT	PANEL / CIRCUIT	CONDUIT / CONDUCTOR SIZE	NOTES
		HP	AMP	WATT	VA	VOLT	Φ				
14-IU-1	AC INDOOR UNIT	-	34.2	-	-	208	1	X	14-N2-1-23,25	0.75" C, 2#6, 1#10 GND	INTEGRAL CONTROLLER
14-CU-1	CONDENSING UNIT	-	20.5	-	-	208	1	X	14-N2-1-27,29	0.75" C, 2#10, 1#10 GND	INTEGRAL CONTROLLER
14-DDC-1	DDC FOR INDOOR UNIT	-	-	50	-	120	1	N/A	14-N1-1-17	0.75" C, 1#12, 1#12 NEUT, 1#12 GND	COORDINATE WITH MECH FOR LOCATION
RK-105-1A	TELECOM CABINET RECEPTACLE	-	-	1920	-	120	1	N/A	14-N1-1-37	0.75" C, 1#12, 1#10 NEUT, 1#12 GND	-
RK-105-1B	TELECOM CABINET RECEPTACLE	-	-	1920	-	120	1	N/A	14-N2-1-15	0.75" C, 1#12, 1#10 NEUT, 1#12 GND	-
14-RECP-1	CONVENIENCE RECEPTACLE	-	-	-	180	120	1	N/A	14-N1-1-17	0.75" C, 2#12, 1#12 GND	PROVIDE GFCI, WEATHERPROOF CONVENIENCE RECEPTACLE

GENERAL NOTES:

- A. SEE EQUIPMENT SCHEDULE ON THIS SHEET FOR POWER REQUIREMENTS.
- B. COORDINATE LIGHTING LAYOUT WITH RACK AND CABLE TRAY LOCATIONS TO PROVIDE ILLUMINATION ON EQUIPMENT PER LIGHTING DESIGN REQUIREMENTS.
- C. COORDINATE WITH MECHANICAL DRAWINGS FOR EQUIPMENT LOCATIONS AND CONDUIT/PIPE ROUTING PRIOR TO ROUGH-IN.

SHEET NOTES:

1. PANEL '14-N2-1'; FOR SECOND SOURCE OF RACK POWER, IS LOCATED ON SECOND FLOOR ABOVE PANEL '14-N1-1'.
2. PROVIDE RACEWAY AND BOXES FOR ACCESS CONTROLS SYSTEM COMPONENTS. SEE EK-104 FOR TYPICAL DOOR DETAIL.

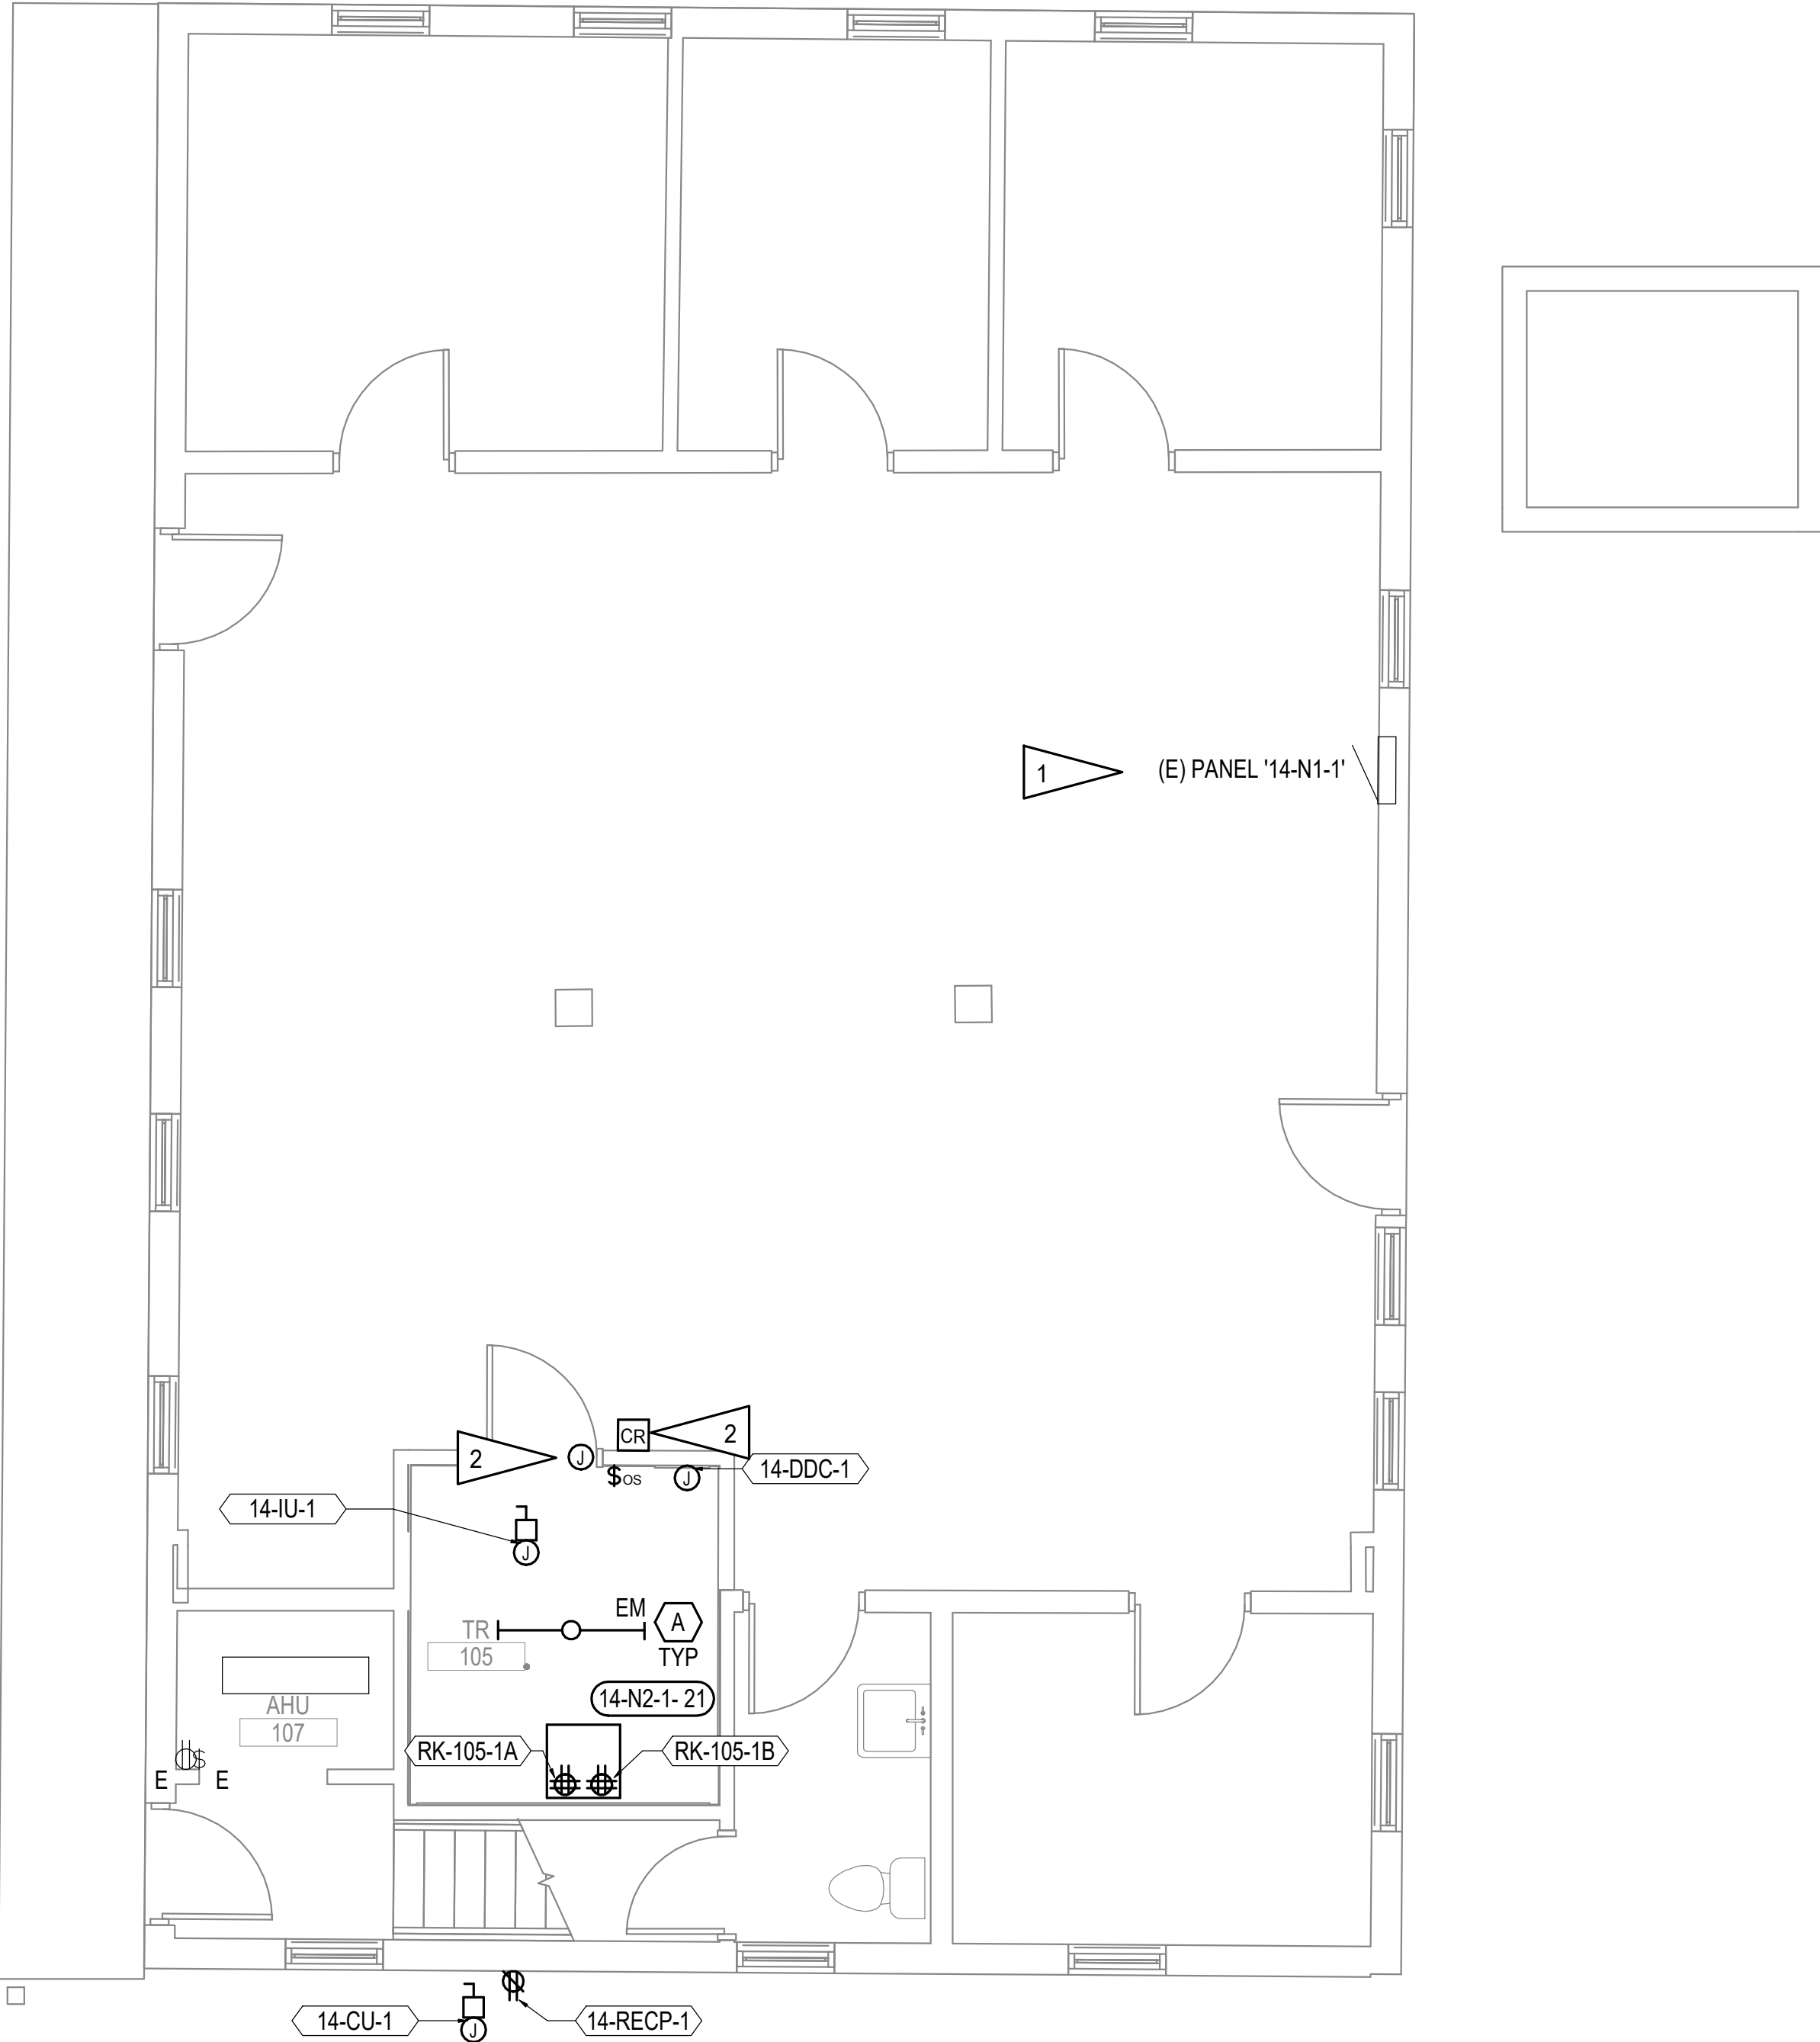

SITE LEGEND



1 ELECTRICAL REMODEL PLAN - BLDG 14 FIRST FLOOR
1/4" = 1'-0"



Revisions:	Date:

CONSULTANT

A/E:
GDM
1000 W STEUBEN ST. UNIT 3
BINGEN, WA 98605
541.436.4723
ADAM GOODIN, PE

ARCHITECT/ENGINEER OF RECORD

MECHANICAL AND ELECTRICAL CONSULTING ENGINEERS
670 West Firwood Lane, Suite 200
Anchorage, AK 99503
Phone (907) 276-0521
Corporate No.: AEC0542

STAMP

PROGRAM CONTRACTING ACTIVITY CENTRAL (PCAC)

U.S. Department of Veterans Affairs

DRAWING TITLE

ELECTRICAL REMODEL PLAN - BLDG 14

APPROVED: Project Director

PHASE

100% CD FINAL SOLUTION

FLS

FULLY SPRINKLERED

PROJECT TITLE

EHRM INFRASTRUCTURE UPGRADES

LOCATION

HOT SPRINGS, SOUTH DAKOTA

ISSUE DATE

02/22/2022

CHECKED BY

JAM

DRAWN BY

CSZ

PROJECT NUMBER

568A4-21-702

BUILDING NUMBER



14

DRAWING NUMBER

014-EP-0G1

- A. SEE EQUIPMENT SCHEDULE ON THIS SHEET FOR POWER REQUIREMENTS.
- B. COORDINATE LIGHTING LAYOUT WITH RACK AND CABLE TRAY LOCATIONS TO PROVIDE ILLUMINATION ON EQUIPMENT PER LIGHTING DESIGN REQUIREMENTS.
- C. COORDINATE WITH MECHANICAL DRAWINGS FOR EQUIPMENT LOCATIONS AND CONDUIT/PIPE ROUTING PRIOR TO ROUGH-IN.


ID TAG	EQUIPMENT DESCRIPTION	ELECTRICAL DATA						REQUIRES DISCONNECT	PANEL / CIRCUIT	CONDUIT / CONDUCTOR SIZE	NOTES
		HP	AMP	WATT	VA	VOLT	Φ				
RK-101-1A	TELECOM CABINET RECEPTACLE	-	-	1920	-	120	1	N/A	17-N1-1-20	0.75" C, #12, #10 NEUT, #12 GND	-
RK-101-1B	TELECOM CABINET RECEPTACLE	-	-	1920	-	120	1	N/A	17-N1-2-37	0.75" C, #12, #10 NEUT, #12 GND	-

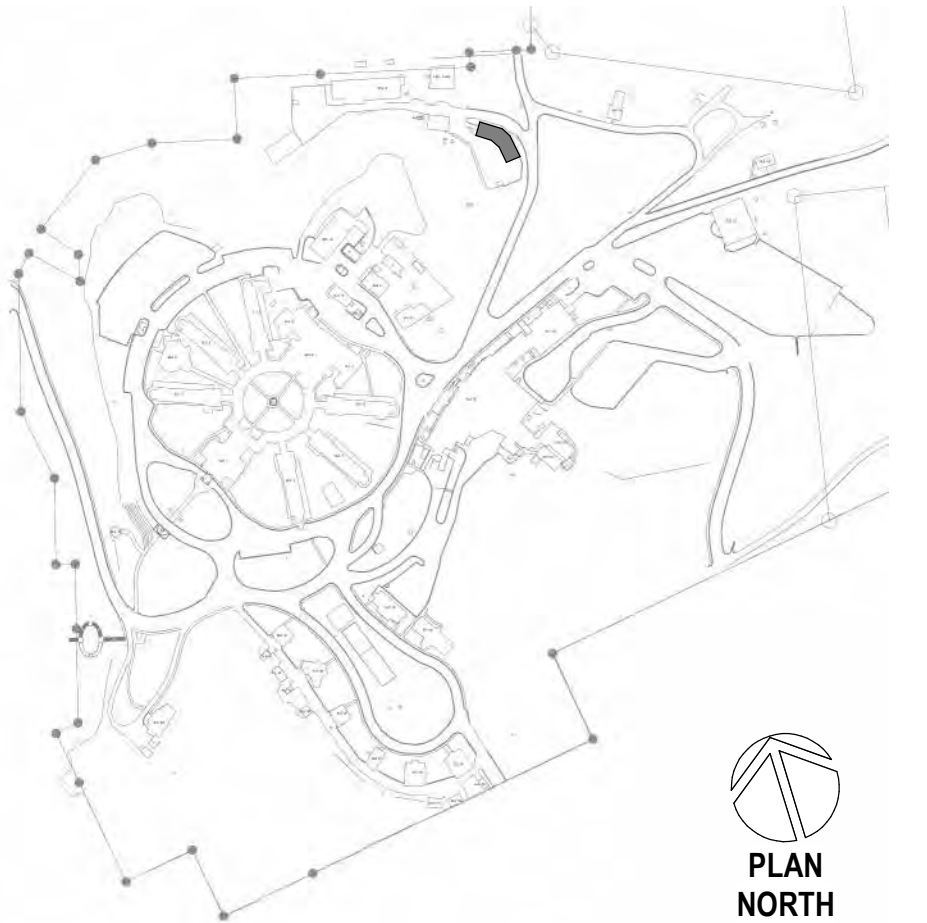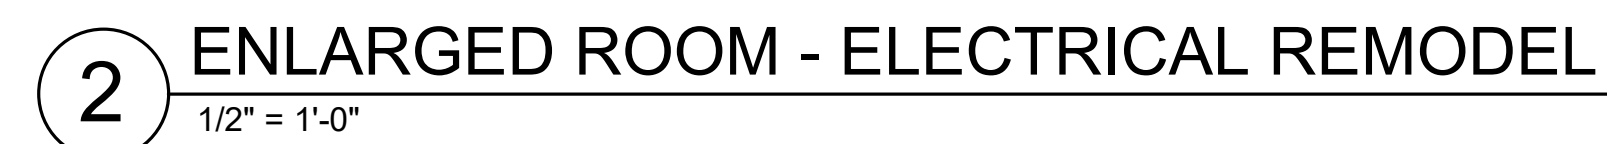[illegible]

CONSULTANT
A/E:
GDM
1000 W STEUBEN ST. UNIT 3
BINGEN, WA 98605
541.436.4723
ADAM GOODIN, PE



RSA
Engineering, Inc.
MECHANICAL AND ELECTRICAL CONSULTING ENGINEERS
670 West Fireweed Lane, Suite 200
Anchorage, AK 99503
Phone (907) 276-0521
Corporate No.: AECC542

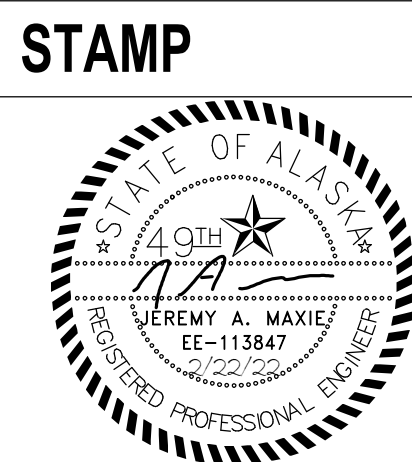

VA | U.S. Department
of Veterans Affairs

APPROVED: Project Director

ISSUE DATE
02/22/2022

CHECKED BY
JAM

KOTA	
DRAWN BY	
CSZ	

PROJECT NUMBER
568A4-21-702
BUILDING NUMBER
17
DRAWING NUMBER
017-EP-011



A. SEE EQUIPMENT SCHEDULE ON THIS SHEET FOR POWER REQUIREMENTS.

B. COORDINATE WITH MECHANICAL DRAWINGS FOR EQUIPMENT LOCATIONS AND CONDUIT/PIPE ROUTING PRIOR TO ROUGH-IN.



PROJECT NUMBER
568A4-21-702

BUILDING NUMBER
18

DRAWING NUMBER
018-EP-011

EQUIPMENT SCHEDULE - BUILDING 20




ID TAG	EQUIPMENT DESCRIPTION	ELECTRICAL DATA						REQUIRES DISCONNECT	PANEL / CIRCUIT	CONDUIT / CONDUCTOR SIZE	NOTES
		HP	AMP	WATT	VA	VOLT	Ø				
RK-001-1A	TELECOM CABINET RECEPTACLE	-	-	1920	-	120	1	N/A	20-LB2-11	0.75" C, 1#12, 1#10 NEUT, 1#12 GND	-
RK-001-1B	TELECOM CABINET RECEPTACLE	-	-	1920	-	120	1	N/A	20-LB-T1-1	0.75" C, 1#12, 1#10 NEUT, 1#12 GND	-

GENERAL NOTES:


- A. SEE EQUIPMENT SCHEDULE ON THIS SHEET FOR POWER REQUIREMENTS.
- B. COORDINATE WITH MECHANICAL DRAWINGS FOR EQUIPMENT LOCATIONS AND CONDUIT/PIPE ROUTING PRIOR TO ROUGH-IN.

SHEET NOTES:

1. INSTALL NEW CIRCUIT BREAKER IN SPACE AVAILABLE IN THE DISTRIBUTION PANEL. THE NEW CIRCUIT BREAKER SHALL BE COMPATIBLE WITH AND LISTED FOR USE IN THE PANEL AND SHALL HAVE A MINIMUM SHORT CIRCUIT AIC RATING TO MATCH THE LOWEST RATED EXISTING DEVICE IN THE PANEL.

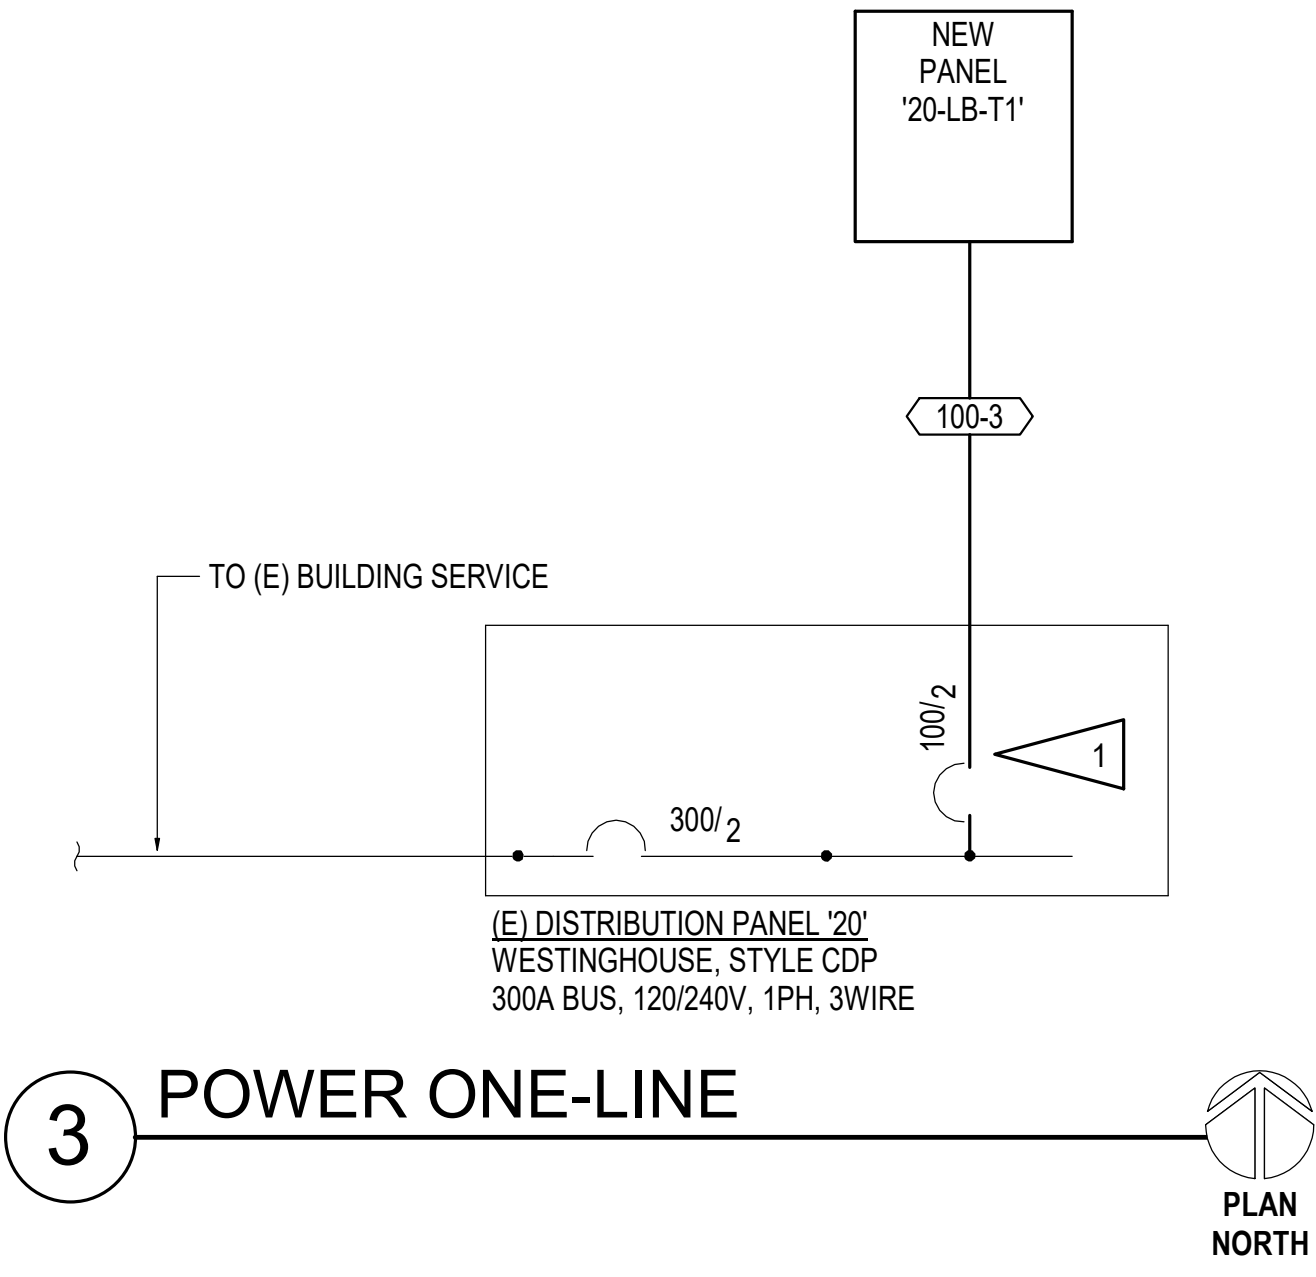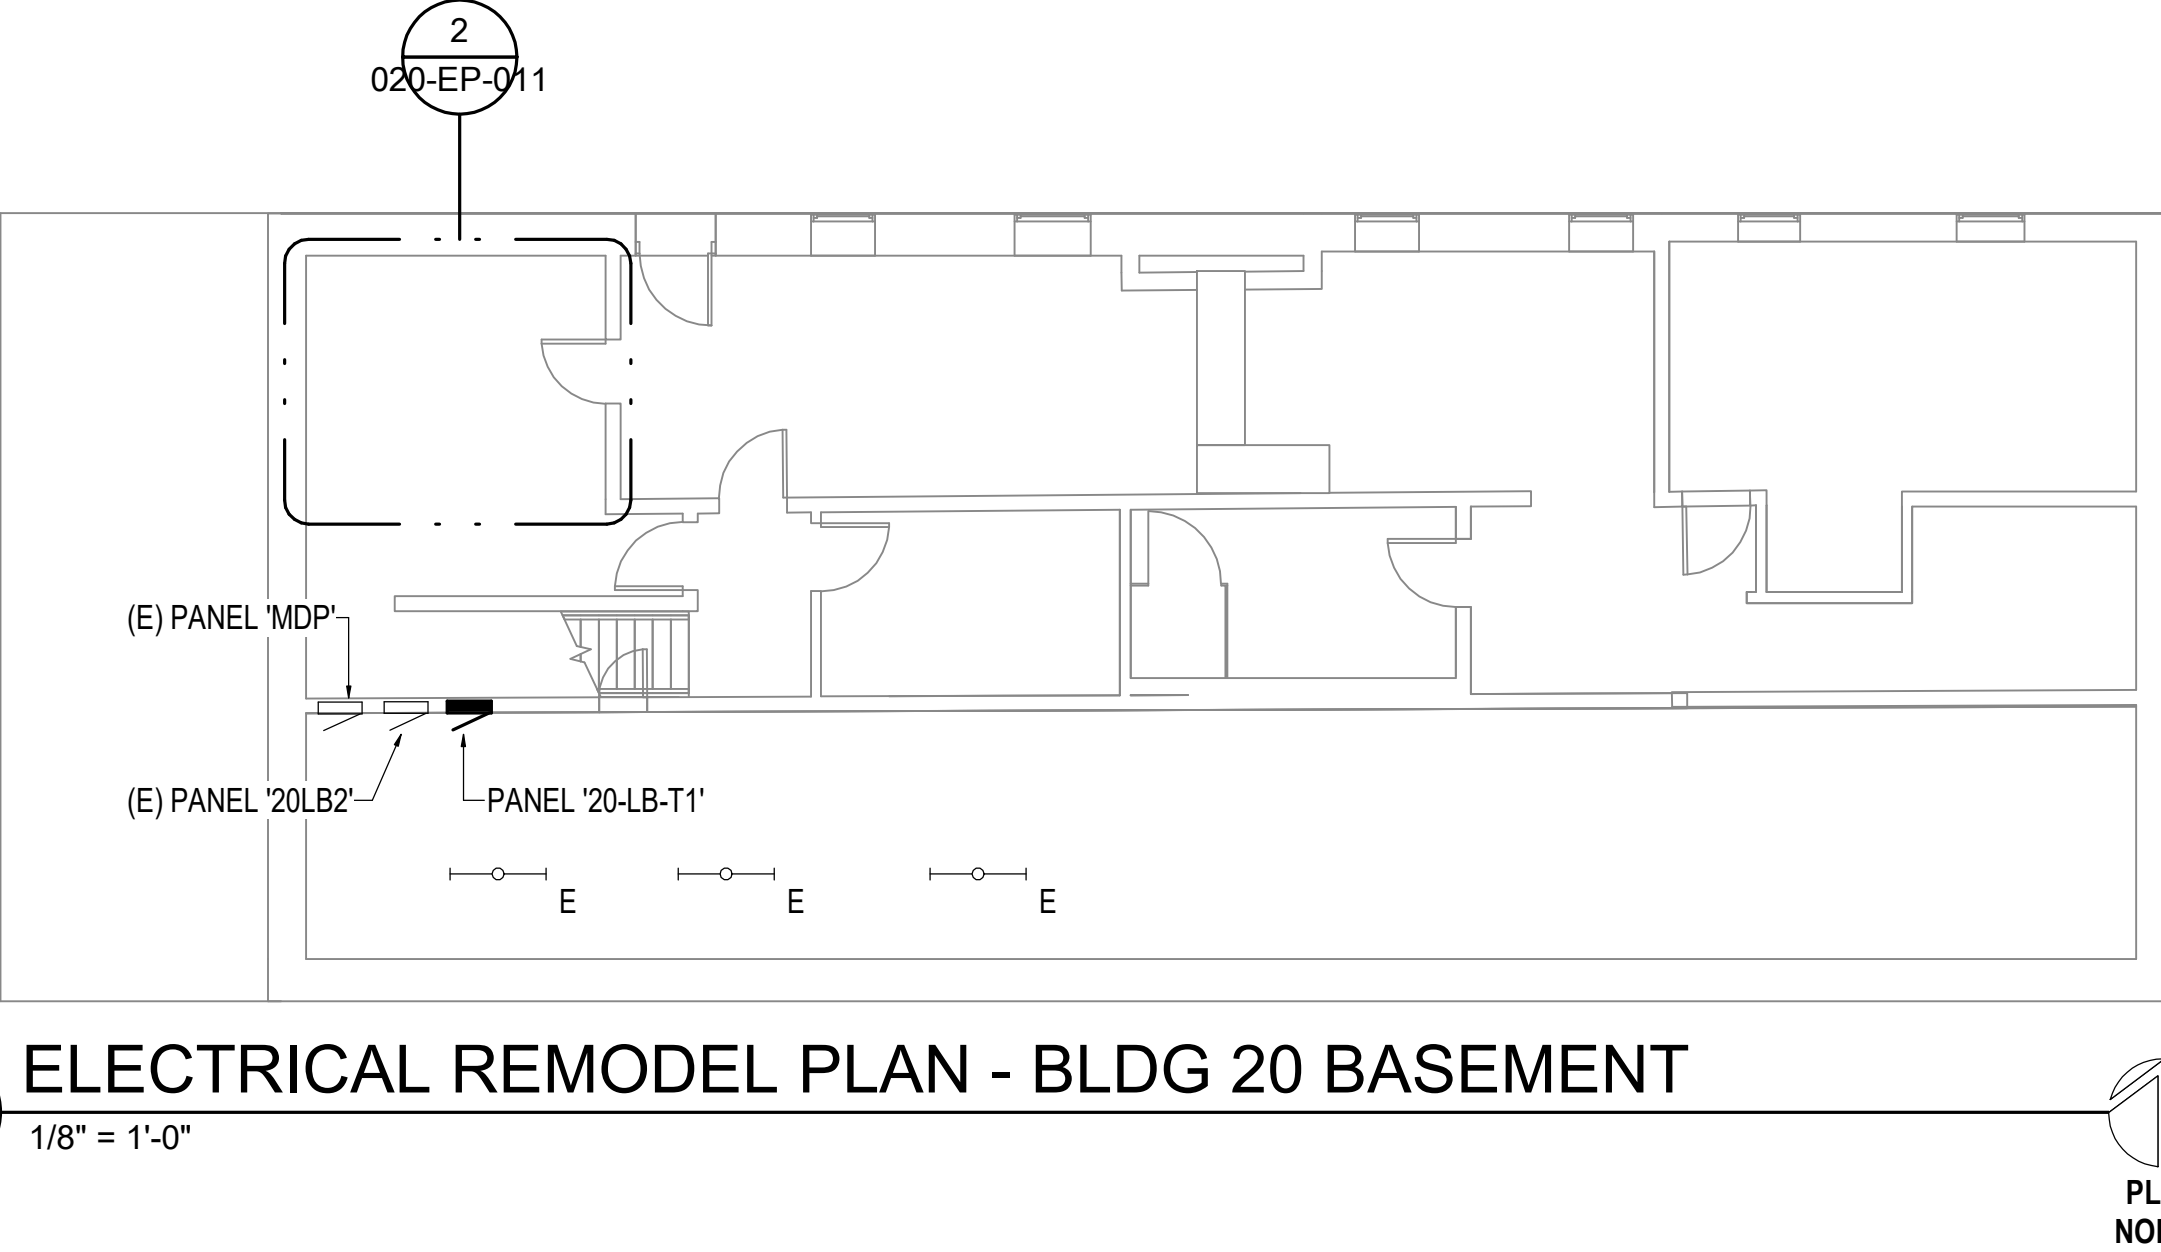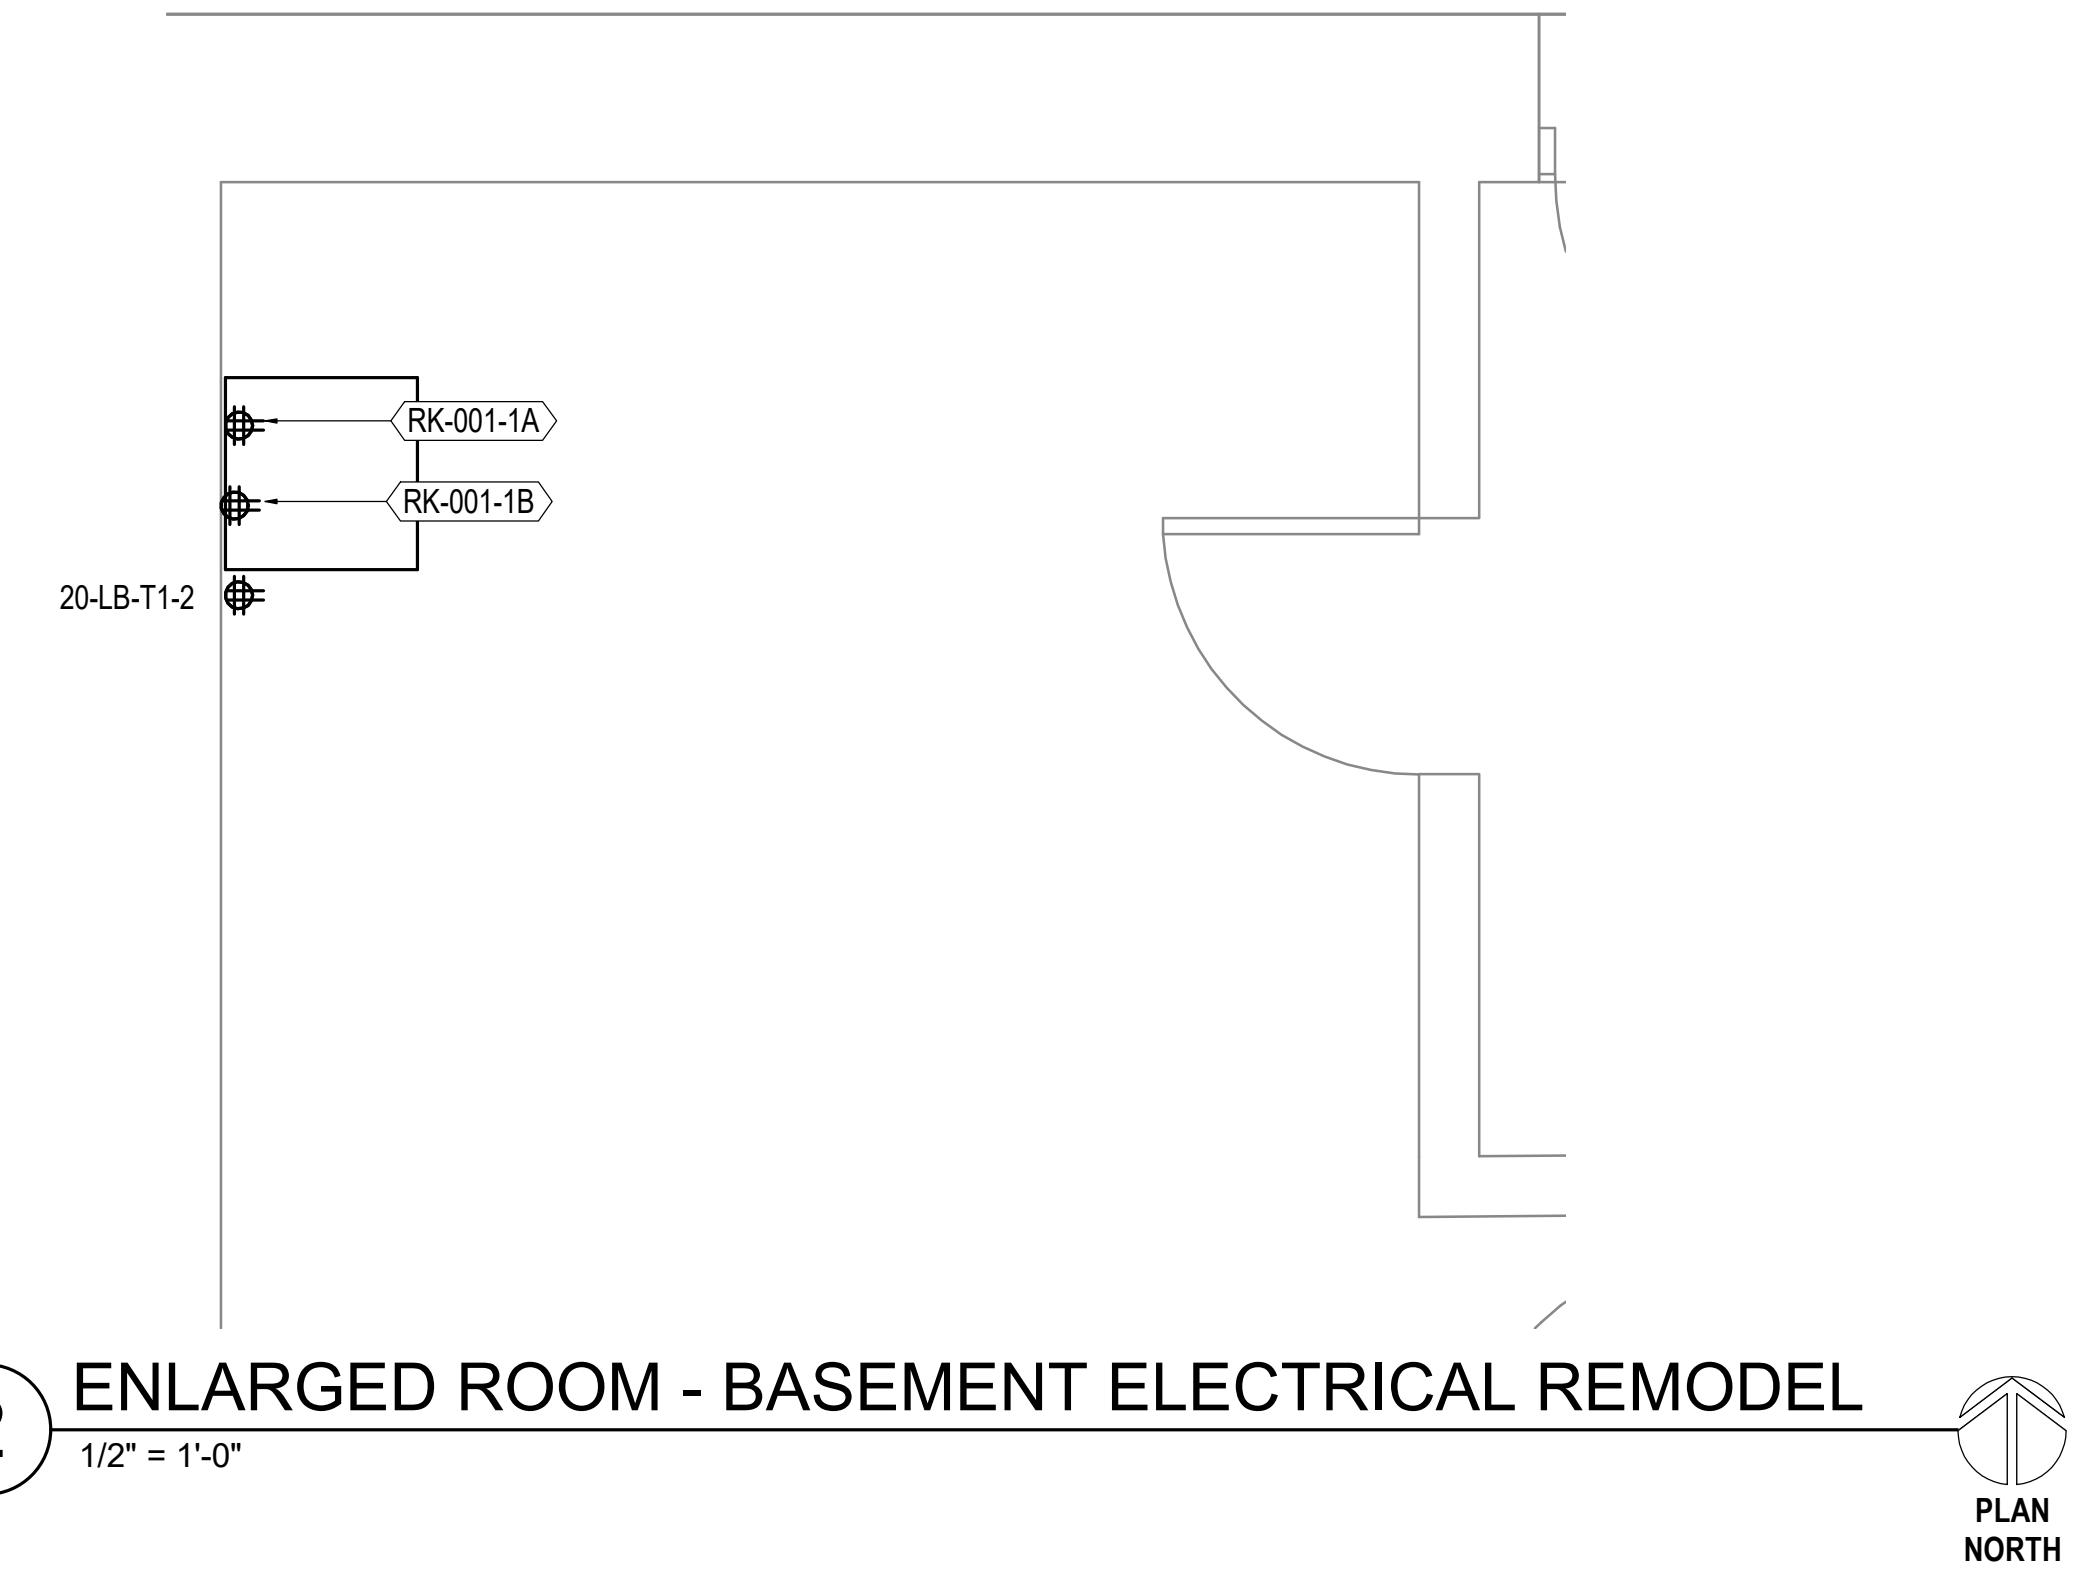

SITE LEGEND

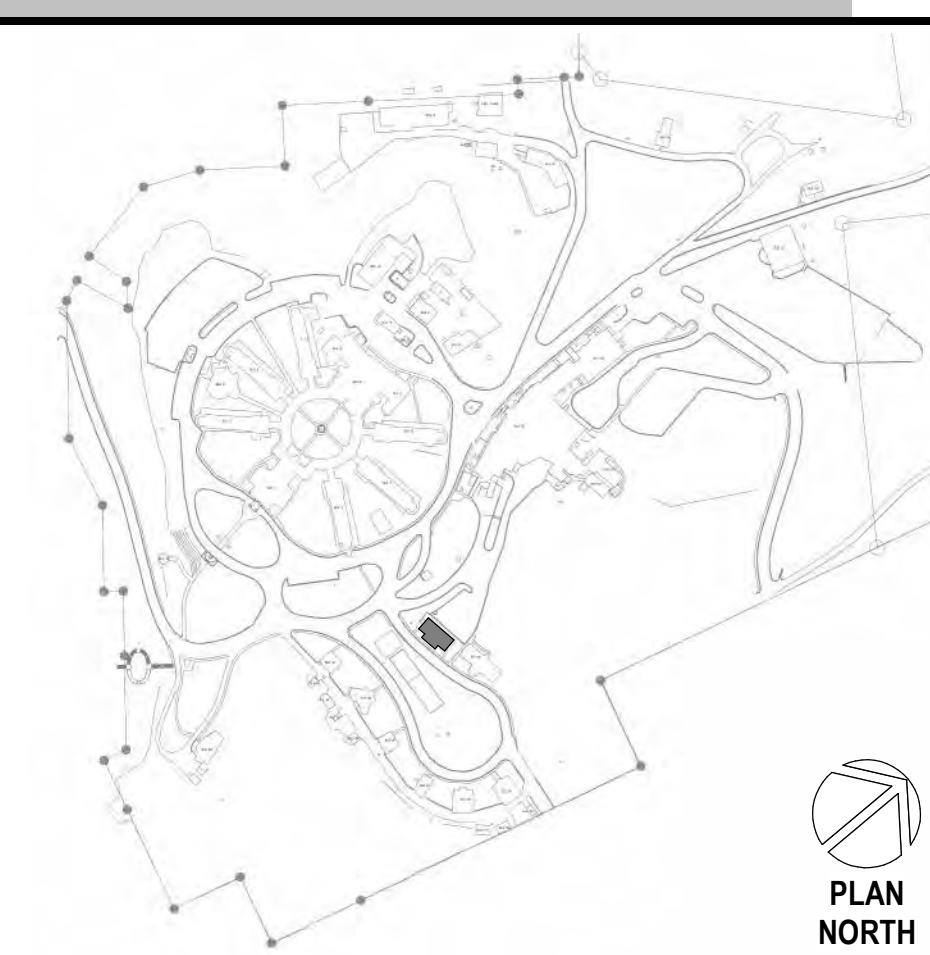

Revisions:	Date:

CONSULTANT

A/E:
GDM
1000 W STEUBEN ST. UNIT 3
BINGEN, WA 98605
541.436.4723
ADAM GOODIN, PE

GDM
ARCHITECTS • ENGINEERS

ARCHITECT/ENGINEER OF RECORD

RSA
Engineering, Inc.
MECHANICAL AND ELECTRICAL CONSULTING ENGINEERS
670 West Firweed Lane, Suite 200
Anchorage, AK 99503
Phone (907) 276-0521
Corporate No.: AECC542

STAMP

STATE OF ALASKA
JEREMY A. MAXIE
REGISTERED PROFESSIONAL ENGINEER
0000000000

PROGRAM CONTRACTING ACTIVITY CENTRAL (PCAC)

U.S. Department of Veterans Affairs

DRAWING TITLE
ELECTRICAL REMODEL PLAN - BLDG 20

APPROVED: Project Director

PHASE
100% CD FINAL SOLUTION

FLS
FULLY SPRINKLERED

PROJECT TITLE
EHRM INFRASTRUCTURE UPGRADES

LOCATION
HOT SPRINGS, SOUTH DAKOTA

ISSUE DATE
02/22/2022

CHECKED BY
JAM

DRAWN BY
CSZ

PROJECT NUMBER
568A4-21-702

BUILDING NUMBER
20

DRAWING NUMBER
020-EP-011

A

B

C

D

E

F

A

B

C

D

E


F

GENERAL NOTES:

- A. SEE EQUIPMENT SCHEDULE ON THIS SHEET FOR POWER REQUIREMENTS.
- B. COORDINATE WITH MECHANICAL DRAWINGS FOR EQUIPMENT LOCATIONS AND CONDUIT/PIPE ROUTING PRIOR TO ROUGH-IN.

EQUIPMENT SCHEDULE - BUILDING 23

ID TAG	EQUIPMENT DESCRIPTION	ELECTRICAL DATA						REQUIRES DISCONNECT	PANEL / CIRCUIT	CONDUIT / CONDUCTOR SIZE	NOTES
		HP	AMP	WATT	VA	VOLT	Ø				
RK-104-1A	TELECOM CABINET RECEPTACLE	-	-	1920	-	120	1	N/A	23-NB-1-34	0.75" C, 1#12, 1#10 NEUT, 1#12 GND	-
RK-104-1B	TELECOM CABINET RECEPTACLE	-	-	1920	-	120	1	N/A	23-N1-1-1	0.75" C, 1#12, 1#10 NEUT, 1#12 GND	-

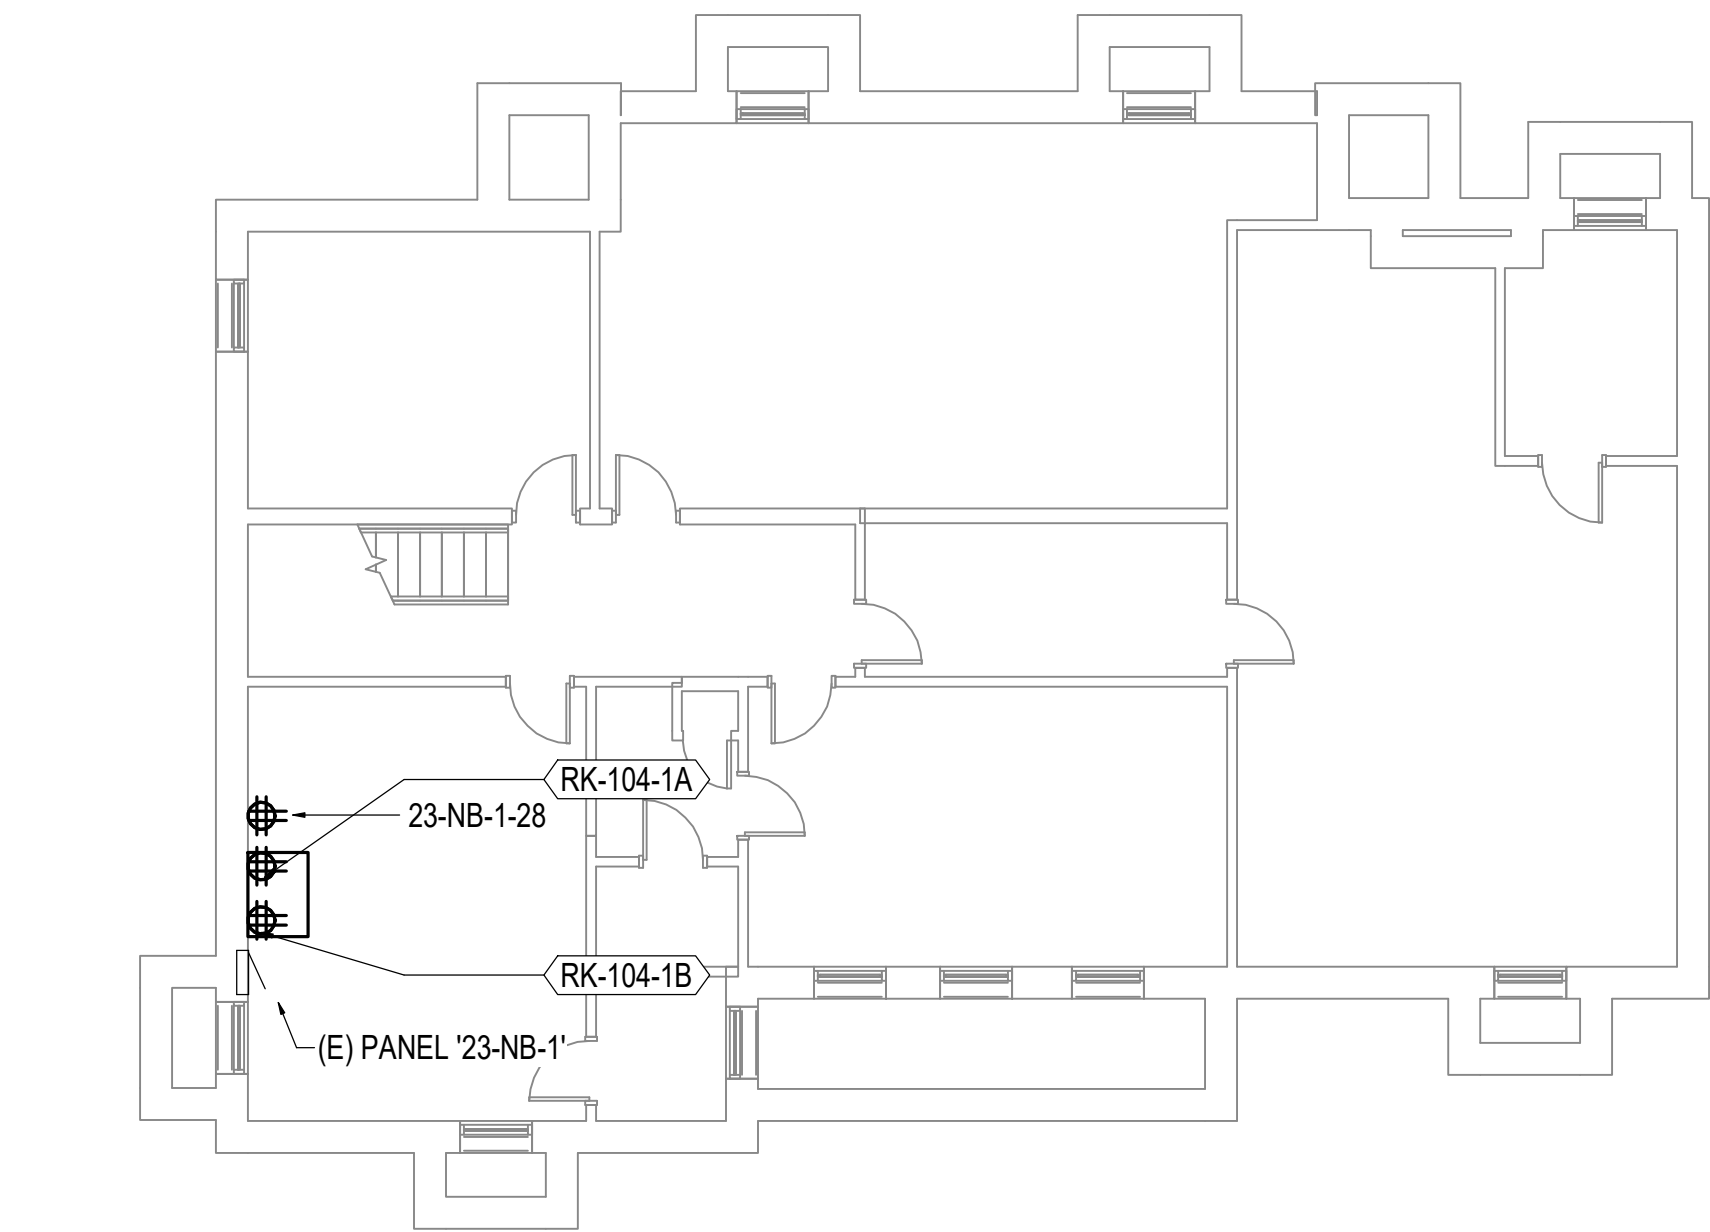


1

ELECTRICAL REMODEL PLAN - BLDG 23 BASEMENT

1/8" = 1'-0"

PLAN NORTH

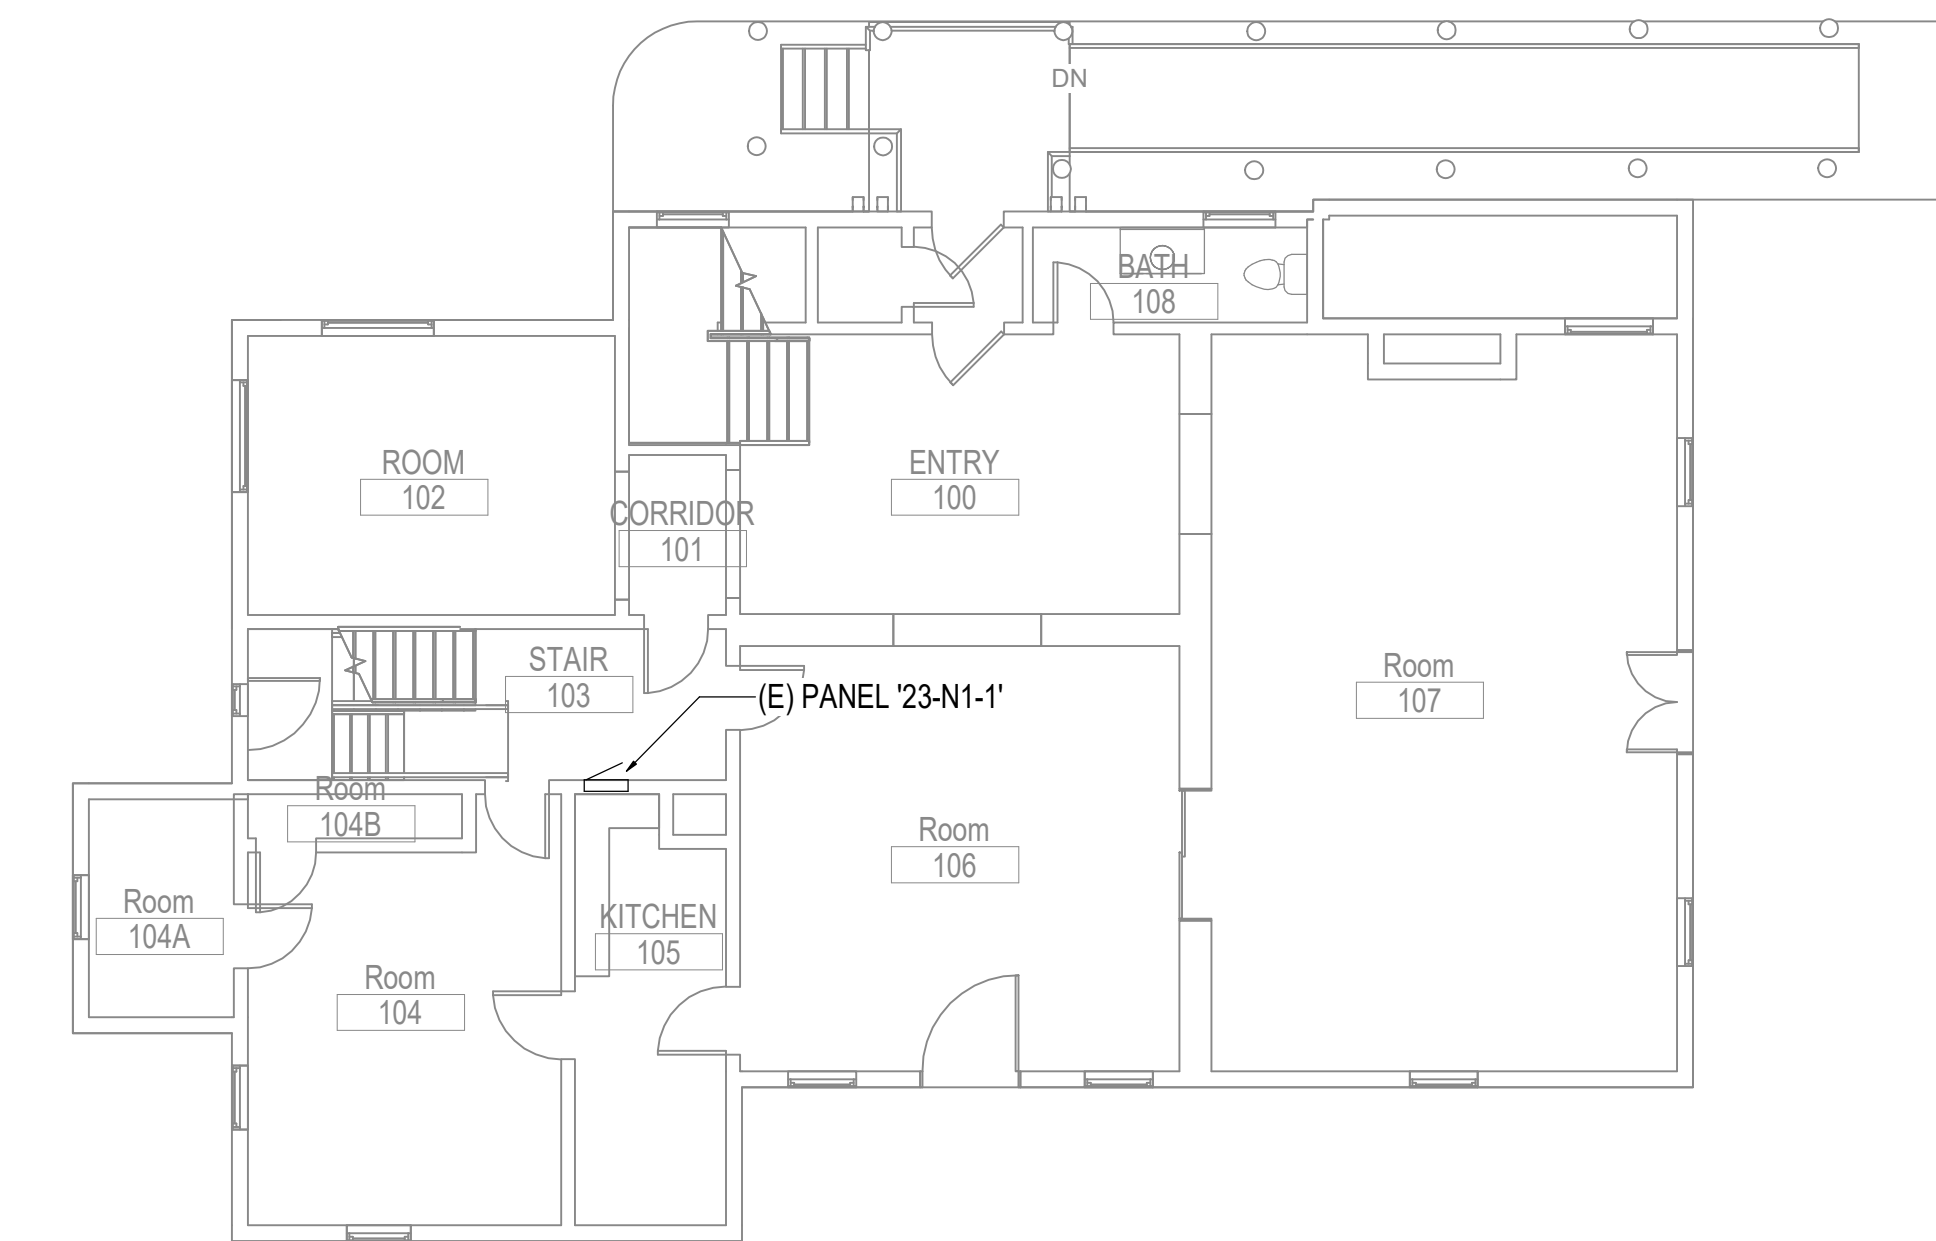

2

ELECTRICAL REMODEL PLAN - BLDG 23 FIRST FLOOR

1/8" = 1'-0"

PLAN NORTH

SITE LEGEND



Revisions:	Date:

CONSULTANT

A/E:
GDM
1000 W STEUBEN ST. UNIT 3
BINGEN, WA 98605
541.436.4723
ADAM GOODIN, PE

GDM
ARCHITECTS • ENGINEERS

ARCHITECT/ENGINEER OF RECORD

RSA
Engineering, Inc.
MECHANICAL AND ELECTRICAL CONSULTING ENGINEERS
670 West Firweed Lane, Suite 200
Anchorage, AK 99503
Phone (907) 276-0521
Corporate No.: AEC0542

STAMP

STATE OF ALASKA
JEREMY A. MAXIE
REGISTERED PROFESSIONAL ENGINEER
No. 113847
Exp. 12/31/2025

PROGRAM CONTRACTING ACTIVITY CENTRAL (PCAC)

VA U.S. Department of Veterans Affairs

DRAWING TITLE

ELECTRICAL REMODEL PLAN - BLDG 23

APPROVED: Project Director

PHASE

100% CD FINAL SOLUTION

FLS

FULLY SPRINKLERED

PROJECT TITLE

EHRM INFRASTRUCTURE UPGRADES

LOCATION

HOT SPRINGS, SOUTH DAKOTA

ISSUE DATE

02/22/2022

CHECKED BY

JAM

DRAWN BY

CK

PROJECT NUMBER

568A4-21-702

BUILDING NUMBER

23

DRAWING NUMBER

023-EP-0B1

A. SEE EQUIPMENT SCHEDULE ON THIS SHEET FOR POWER REQUIREMENTS.

B. COORDINATE WITH MECHANICAL DRAWINGS FOR EQUIPMENT LOCATIONS AND CONDUIT/PIPE ROUTING PRIOR TO ROUGH-IN.

B

D



F

PLAN
NORTH

CONSULTANT

A/E:
GDM
1000 W STEUBEN ST. UNIT 3
BINGEN, WA 98605
541.436.4723
ADAM GODDIN, PE

GDM
ARCHITECTS • ENGINEERS

DRAWING TITLE

ELECTRICAL REMODEL PLAN - BLDG 29

APPROVED: Project Director

PROJECT TITLE		
EHRM INFRASTRUCTURE UPGRADES		
LOCATION		
HOT SPRINGS, SOUTH DAKOTA		
ISSUE DATE	CHECKED BY	DRAWN BY
02/22/2022	JAM	CSZ

PROJECT NUMBER
568A4-21-702

BUILDING NUMBER
29

DRAWING NUMBER
029-EP-0B1

GENERAL NOTES:

- A. SEE EQUIPMENT SCHEDULE ON THIS SHEET FOR POWER REQUIREMENTS.
- B. COORDINATE LIGHTING LAYOUT WITH RACK AND CABLE TRAY LOCATIONS TO PROVIDE ILLUMINATION ON EQUIPMENT PER LIGHTING DESIGN REQUIREMENTS.
- C. COORDINATE WITH MECHANICAL DRAWINGS FOR EQUIPMENT LOCATIONS AND CONDUIT/PIPE ROUTING PRIOR TO ROUGH-IN.



SHEET NOTES:

1. RECEPTACLE AND TELECOM CABINET LOCATED IN BASEMENT BELOW.

EQUIPMENT SCHEDULE - BUILDING 43

ID TAG	EQUIPMENT DESCRIPTION	ELECTRICAL DATA						REQUIRES DISCONNECT	PANEL / CIRCUIT	CONDUIT / CONDUCTOR SIZE	NOTES
		HP	AMP	WATT	VA	VOLT	Ø				
RK-B01-1A	TELECOM CABINET RECEPTACLE	-	-	1920	-	120	1	N/A	43-N1-2-32	0.75"Ø, 1#12, 1#10 NEUT, 1#12 GND	-
RK-B01-1B	TELECOM CABINET RECEPTACLE	-	-	1920	-	120	1	N/A	43-N1-3-9	0.75"Ø, 1#12, 1#10 NEUT, 1#12 GND	-

SITE LEGEND

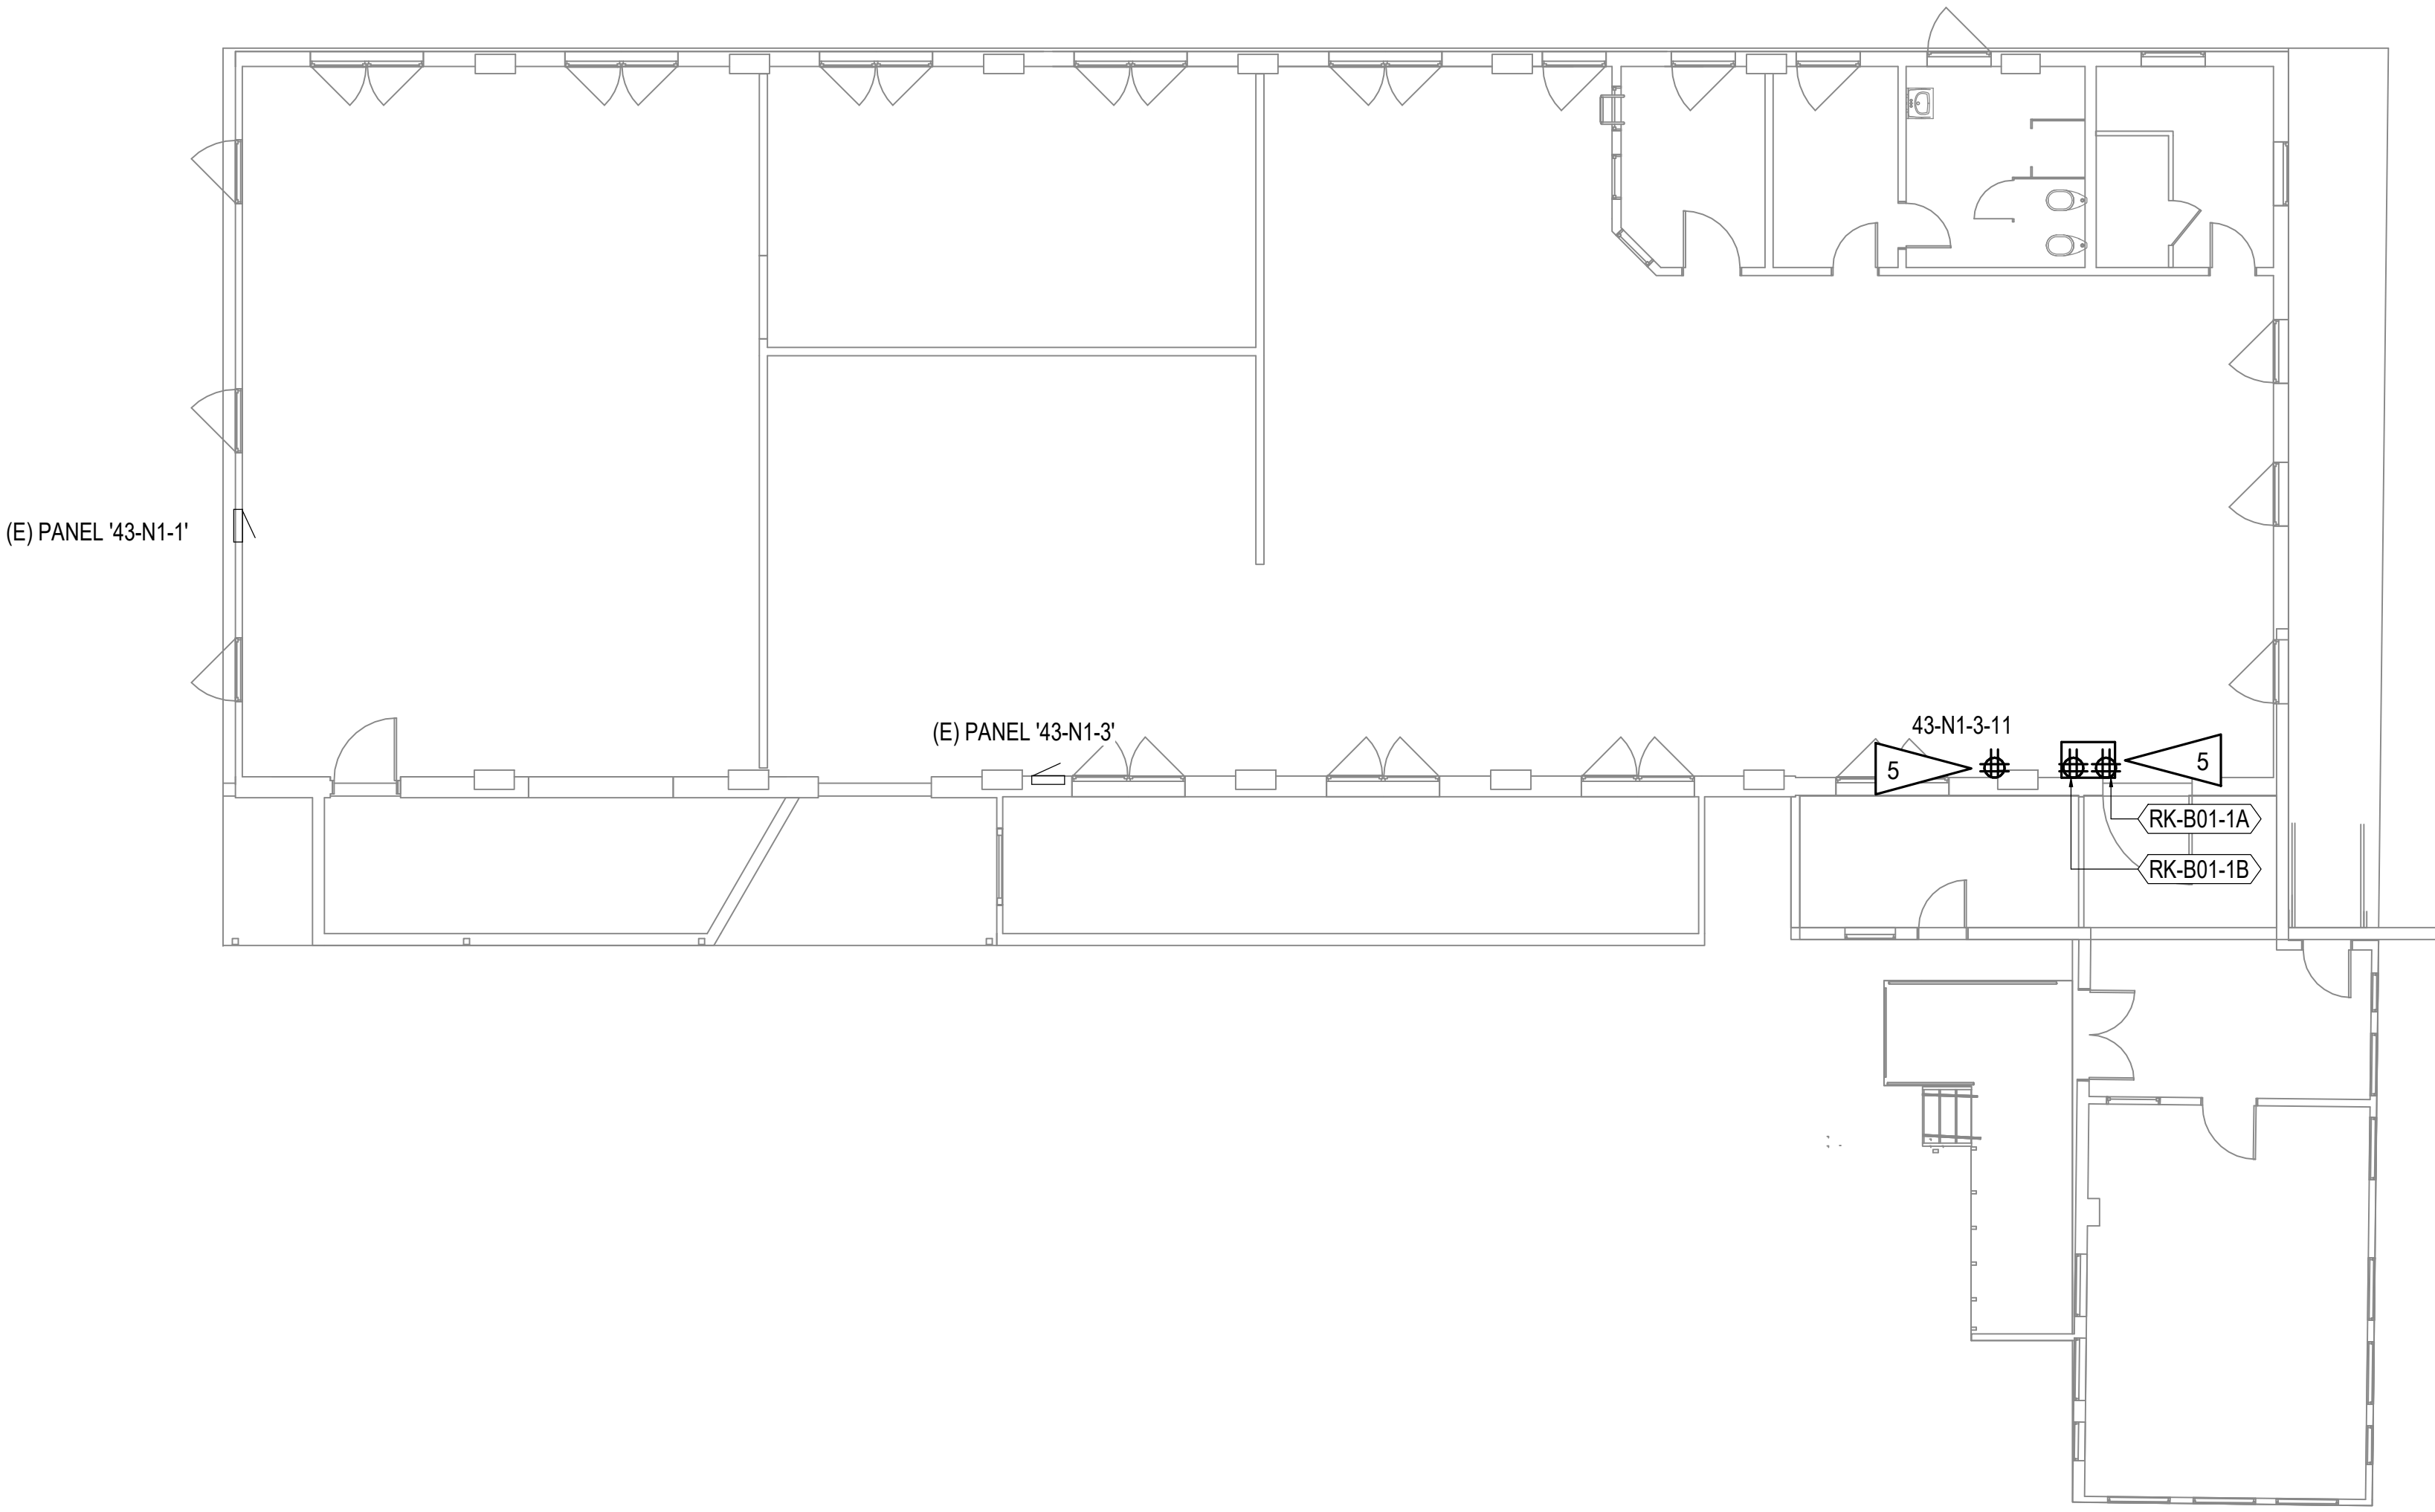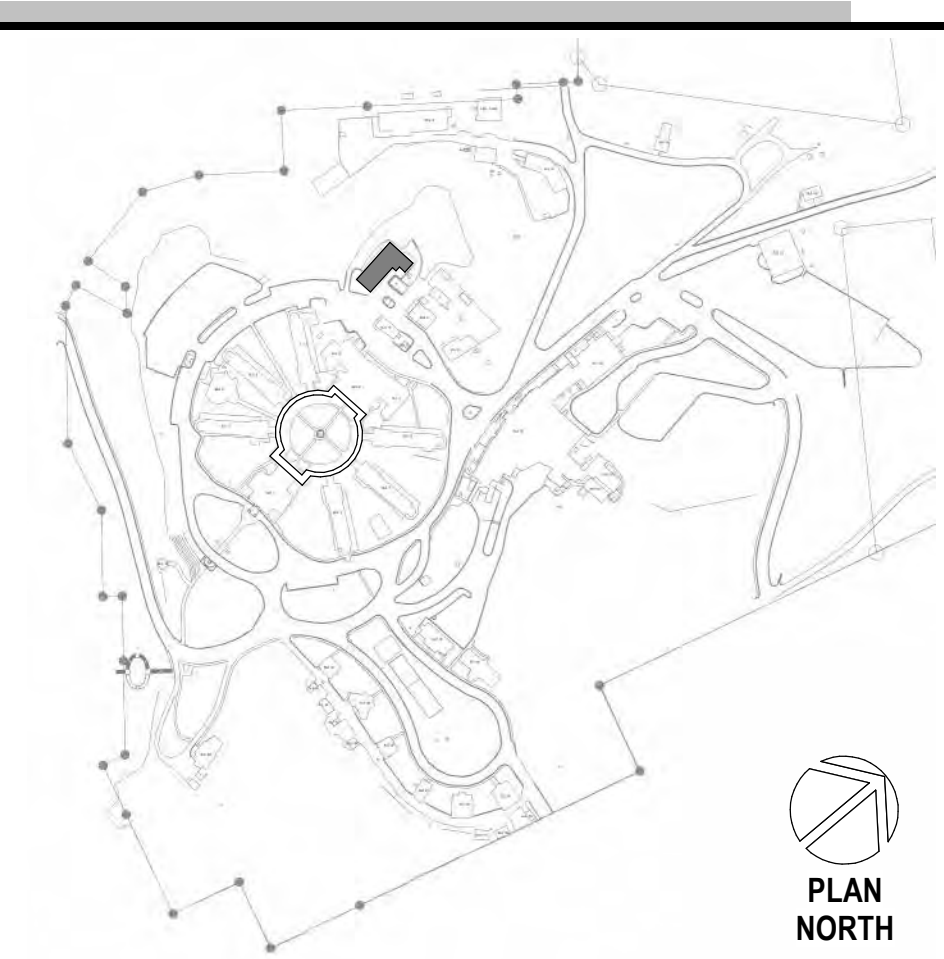

1 ELECTRICAL REMODEL PLAN - BLDG 43 FIRST FLOOR
1/8" = 1'-0"

Revisions:	Date:

CONSULTANT

A/E:
GDM
1000 W STEUBEN ST. UNIT 3
BINGEN, WA 98605
541.436.4723
ADAM GOODIN, PE

ARCHITECT/ENGINEER OF RECORD

MECHANICAL AND ELECTRICAL CONSULTING ENGINEERS
670 West Fireweed Lane, Suite 200
Anchorage, AK 99503
Phone (907) 278-0521
Corporate No.: AEC0542

STAMP

PROGRAM CONTRACTING ACTIVITY CENTRAL (PCAC)

U.S. Department of Veterans Affairs

DRAWING TITLE

ELECTRICAL REMODEL PLAN - BLDG 43

APPROVED: Project Director

PHASE

100% CD FINAL SOLUTION

FLS

FULLY SPRINKLERED

PROJECT TITLE

EHRM INFRASTRUCTURE UPGRADES

LOCATION

HOT SPRINGS, SOUTH DAKOTA

ISSUE DATE

02/22/2022

CHECKED BY

JAM

DRAWN BY

CSZ

PROJECT NUMBER

568A4-21-702

BUILDING NUMBER

43

DRAWING NUMBER

043-EP-011

A

B

C

D

E

F

A

B

C

D

E

F

EQUIPMENT SCHEDULE - BUILDING 53

ID TAG	EQUIPMENT DESCRIPTION	ELECTRICAL DATA						REQUIRES DISCONNECT	PANEL / CIRCUIT	CONDUIT / CONDUCTOR SIZE	NOTES
		HP	AMP	WATT	VA	VOLT	Ø				
53-IU-1	AC INDOOR UNIT	-	46.3	-	-	208	3	X	53-NB-T1-13,15,17	1" C, 3#6, 1#10 GND	INTEGRAL CONTROLLER
53-CU-1	CONDENSING UNIT	-	23.4	-	-	208	3	X	53-NB-T1-7,9,11	0.75" C, 3#10, 1#10 GND	INTEGRAL CONTROLLER
53-DDC-1	DDC FOR INDOOR UNIT	-	-	50	-	120	1	N/A	53-NB-T1-2	0.75" C, 1#12, 1#12 NEUT, 1#12 GND	COORDINATE WITH MECH FOR LOCATION
ZP-102B-1A	TELECOM RACK RECEPTACLE	-	-	10000	-	208	3	N/A	53-NB-T1-1,3,5	0.75" C, 3#10, 1#8 NEUT, 1#10 GND	PROVIDE NEMA L21-30R, SEE 5/000-1-001
ZP-102B-1B	TELECOM RACK RECEPTACLE	-	-	10000	-	208	3	N/A	53-EQB-T1-1,3,5	0.75" C, 3#10, 1#8 NEUT, 1#10 GND	PROVIDE NEMA L21-30R, SEE 5/000-1-001
53-RECP-1	CONVENIENCE RECEPTACLE	-	-	-	180	120	1	N/A	53-NB-T1-6	0.75" C, 2#12, 1#12 GND	PROVIDE GFCI, WEATHERPROOF CONVENIENCE RECEPTACLE

GENERAL NOTES:


- A. SEE EQUIPMENT SCHEDULE ON THIS SHEET FOR POWER REQUIREMENTS.
- B. COORDINATE LIGHTING LAYOUT WITH RACK AND CABLE TRAY LOCATIONS TO PROVIDE ILLUMINATION ON EQUIPMENT PER LIGHTING DESIGN REQUIREMENTS.
- C. COORDINATE WITH MECHANICAL DRAWINGS FOR EQUIPMENT LOCATIONS AND CONDUIT/PIPE ROUTING PRIOR TO ROUGH-IN.

SHEET NOTES:

1. PROVIDE RACEWAY AND BOXES FOR ACCESS CONTROLS SYSTEM COMPONENTS. SEE EK-104 FOR TYPICAL DOOR DETAIL.
2. INSTALL NEW CIRCUIT BREAKER IN SPACE AVAILABLE IN THE DISTRIBUTION PANEL. THE NEW CIRCUIT BREAKER SHALL BE COMPATIBLE WITH AND LISTED FOR USE IN THE PANEL AND SHALL HAVE A MINIMUM SHORT CIRCUIT AIC RATING TO MATCH THE LOWEST RATED EXISTING DEVICE IN THE PANEL.
3. NEW PANEL FED FROM BUILDING 12 PANEL 1IN-EQT1. SEE ONE-LINE ON 1/EK-103.

2 ELECTRICAL REMODEL PLAN - BLDG 53 FIRST FLOOR

1/8" = 1'-0"

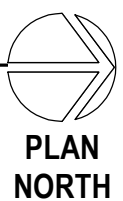

4 POWER ONE-LINE

12" = 1'-0"



1 ELECTRICAL REMODEL PLAN - BLDG 53 BASEMENT

1/8" = 1'-0"




3 ENLARGED ROOM - 102B ELECTRICAL REMODEL

1/2" = 1'-0"



SITE LEGEND

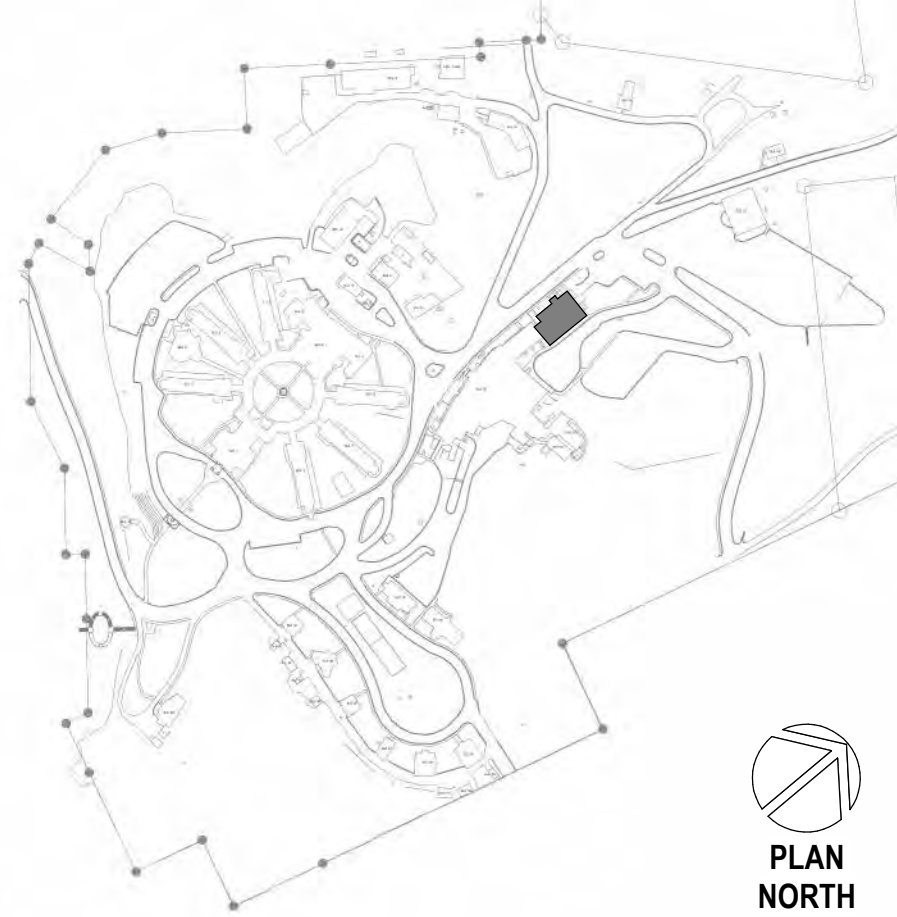

Revisions:	Date:

CONSULTANT

A/E:
GDM
1000 W STEUBEN ST. UNIT 3
BINGEN, WA 98605
541.436.4723
ADAM GODDIN, PE

GDM
ARCHITECTS • ENGINEERS

ARCHITECT/ENGINEER OF RECORD

RSA
Engineering, Inc.
MECHANICAL AND ELECTRICAL CONSULTING ENGINEERS
670 West Firwood Lane, Suite 200
Anchorage, AK 99503
Phone (907) 278-0521
Corporate No.: AEC0542

STAMP

STATE OF ALASKA
JEREMY A. MAXIE
REGISTERED PROFESSIONAL ENGINEER
No. 113847
EXPIRATION DATE 12/31/2023

PROGRAM CONTRACTING ACTIVITY CENTRAL (PCAC)

VA U.S. Department of Veterans Affairs

DRAWING TITLE
ELECTRICAL REMODEL PLAN - BLDG 53

APPROVED: Project Director

PHASE
100% CD FINAL SOLUTION

FLS
FULLY SPRINKLERED

PROJECT TITLE
EHRM INFRASTRUCTURE UPGRADES

LOCATION
HOT SPRINGS, SOUTH DAKOTA

ISSUE DATE
02/22/2022

CHECKED BY
JAM

DRAWN BY
CK

PROJECT NUMBER
568A4-21-702

BUILDING NUMBER
53

DRAWING NUMBER
053-EP-0B1

A

B

C


D

E

F

2/22/2022 5:46:14 PM

C:\Users\JL\OneDrive\Documents\2020\Local\MT121\ESERIES_BLDG_65_201\angent71603.rvt

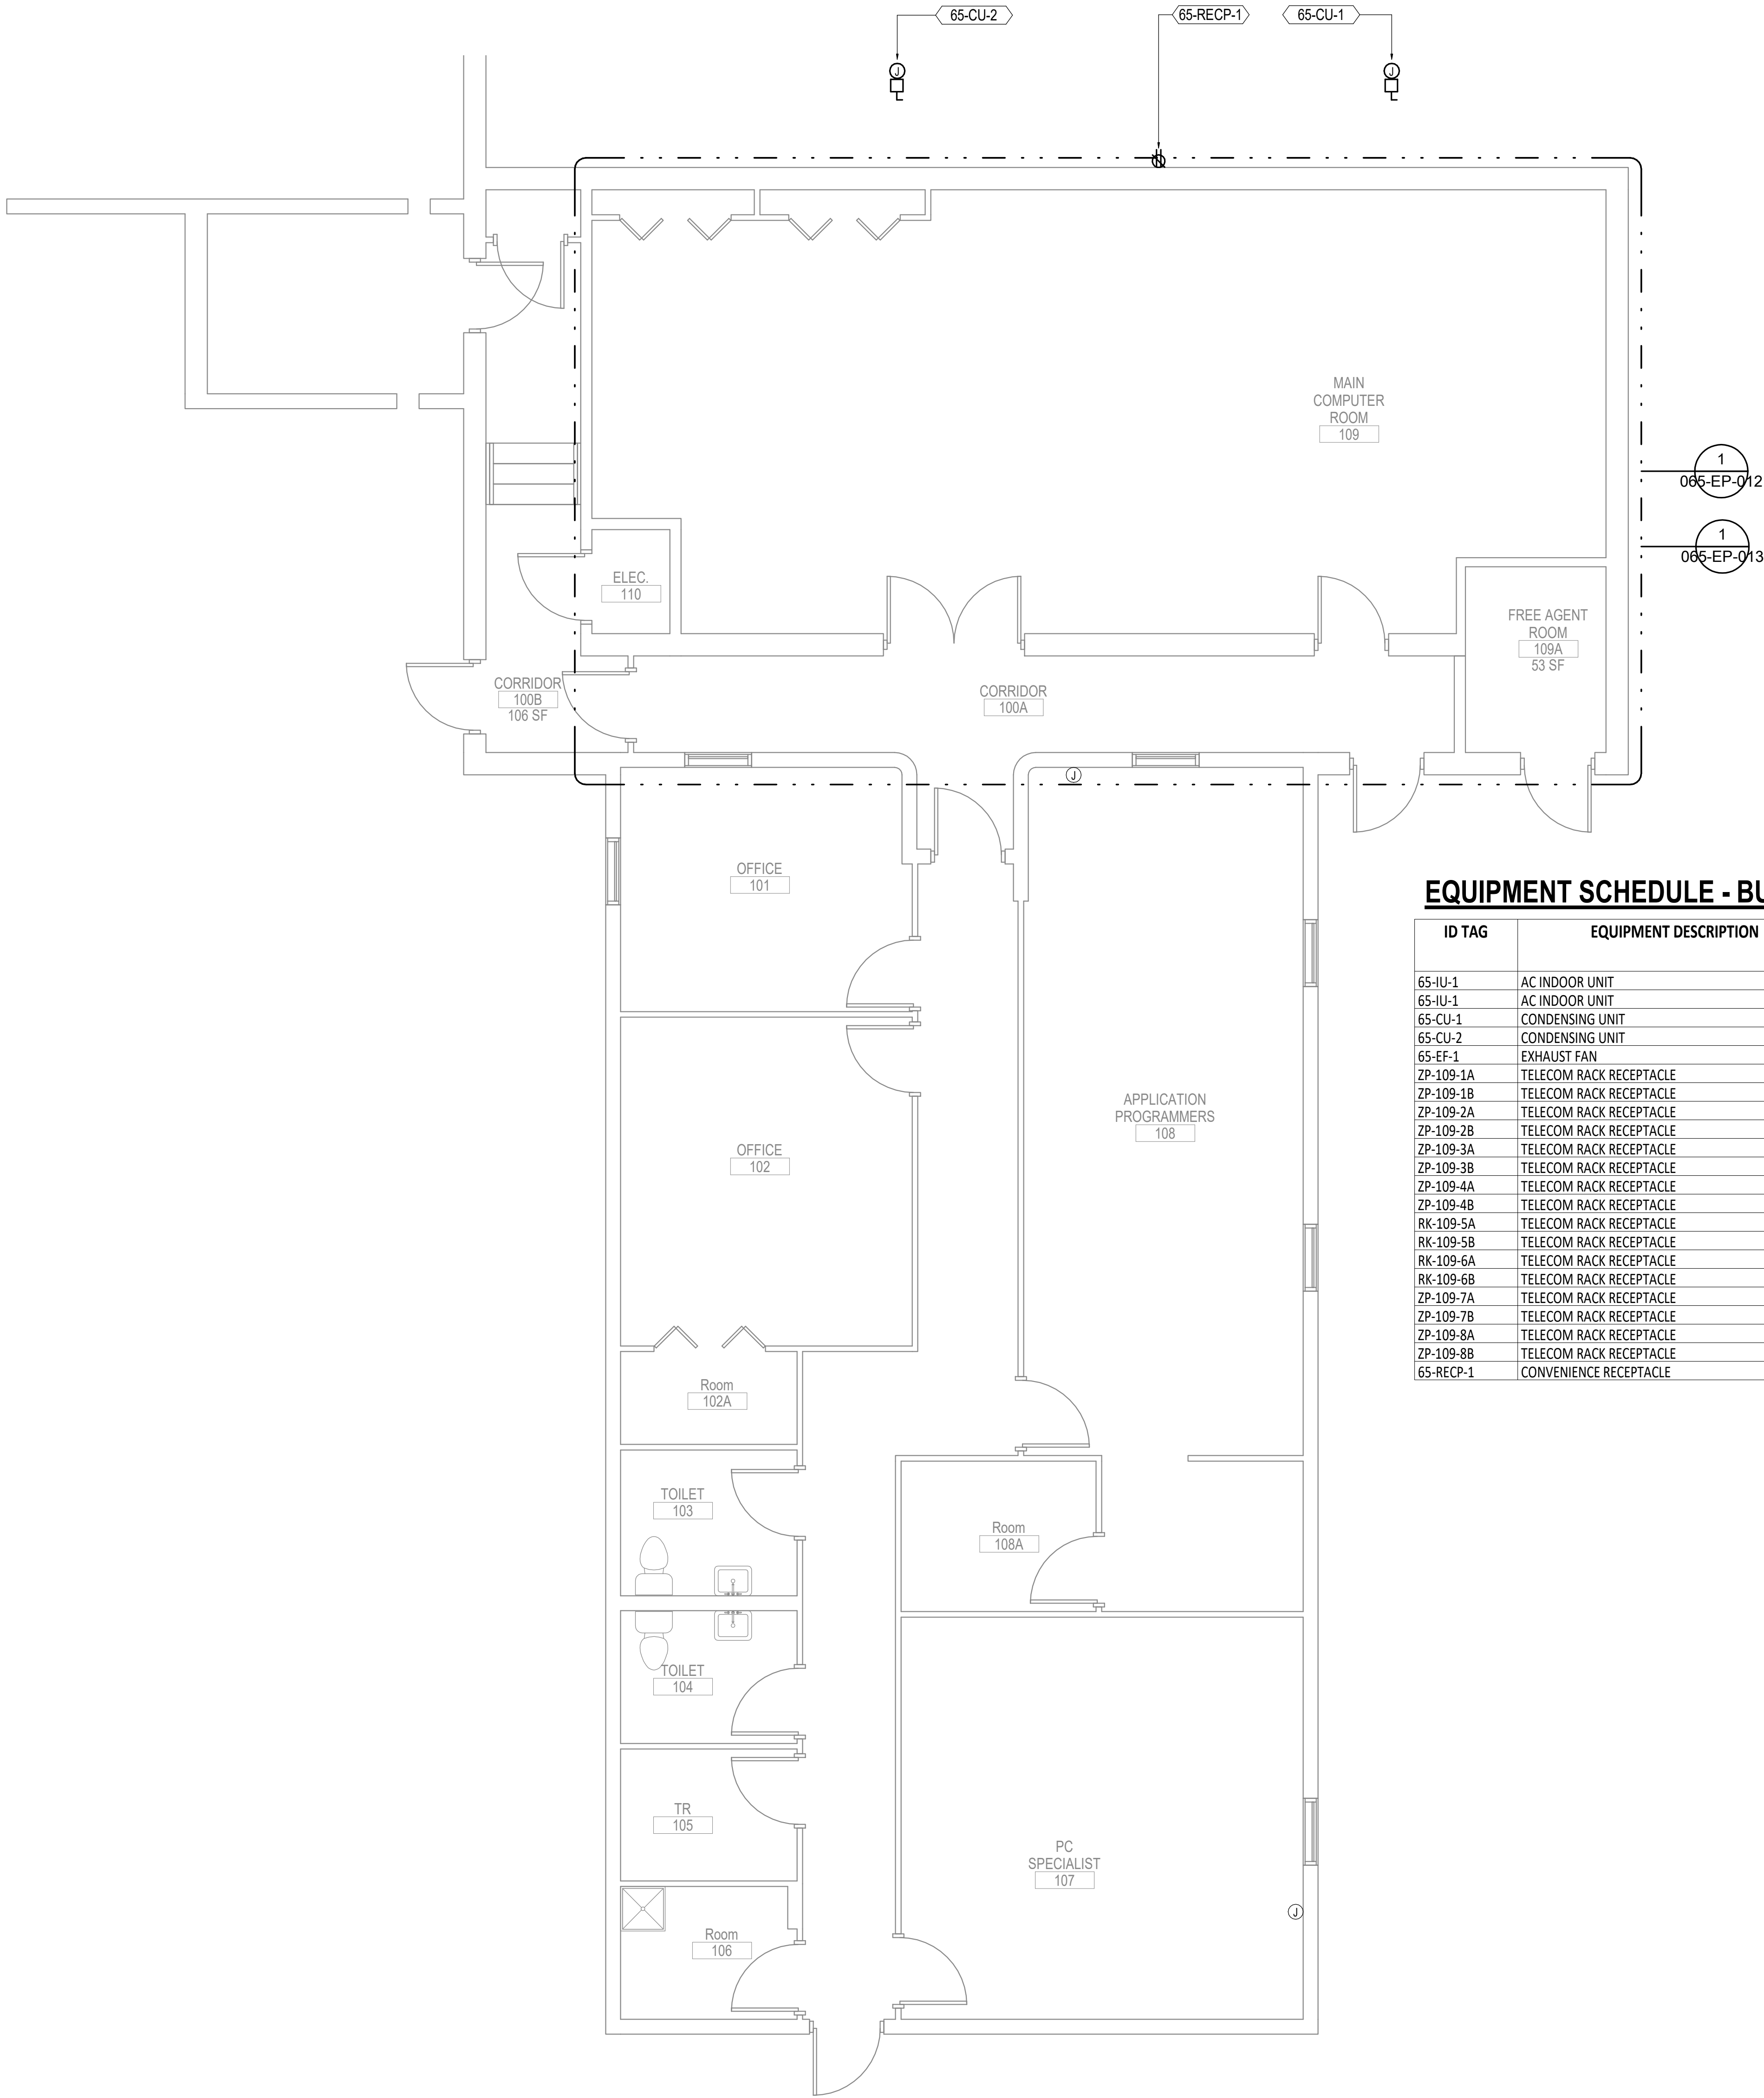

GENERAL NOTES:

- A. SEE EQUIPMENT SCHEDULE ON THIS SHEET FOR POWER REQUIREMENTS.
- B. COORDINATE LIGHTING LAYOUT WITH RACK AND CABLE TRAY LOCATIONS TO PROVIDE ILLUMINATION ON EQUIPMENT PER LIGHTING DESIGN REQUIREMENTS.
- C. COORDINATE WITH MECHANICAL DRAWINGS FOR EQUIPMENT LOCATIONS AND CONDUIT/PIPE ROUTING PRIOR TO ROUGH-IN.


SHEET NOTES:

- 1. EXTEND AND RECONNECT EXISTING MECHANICAL CIRCUITS TO NEW MECHANICAL EQUIPMENT.

EQUIPMENT SCHEDULE - BUILDING 65:

ID TAG	EQUIPMENT DESCRIPTION	ELECTRICAL DATA						REQUIRES DISCONNECT	PANEL / CIRCUIT	CONDUIT / CONDUCTOR SIZE	NOTES
		HP	AMP	WATT	VA	VOLT	Φ				
65-IU-1	AC INDOOR UNIT	-	129.2	-	-	208	3	X	EXISTING	2" C, 3#2/0, 1#6 GND	RECONNECT TO EXISTING CIRCUIT
65-IU-1	AC INDOOR UNIT	-	129.2	-	-	208	3	X	EXISTING	2" C, 3#2/0, 1#6 GND	RECONNECT TO EXISTING CIRCUIT
65-CU-1	CONDENSING UNIT	-	11.4	-	-	208	3	X	EXISTING	0.75" C, 3#12, 1#12 GND	RECONNECT TO EXISTING CIRCUIT, COORDINATE WITH MECH FOR LOCATION
65-CU-2	CONDENSING UNIT	-	11.4	-	-	208	3	X	EXISTING	0.75" C, 3#12, 1#12 GND	RECONNECT TO EXISTING CIRCUIT, COORDINATE WITH MECH FOR LOCATION
65-EF-1	EXHAUST FAN	0.07	-	-	-	120	1	-	UPS-A-25	0.75" C, 2#12, 1#12 GND	PROVIDE FRACTIONAL MOTOR STARTER WITH TOGGLE SWITCH
ZP-109-1A	TELECOM RACK RECEPTACLE	-	-	10500	-	208	3	N/A	UPS-A-1,3,5	1.25" C, 3#4, 1#3 NEUT, 1#10 GND	JUNCTION BOX CONNECTION
ZP-109-1B	TELECOM RACK RECEPTACLE	-	-	10500	-	208	3	N/A	UPS-B-1,3,5	1.25" C, 3#4, 1#3 NEUT, 1#10 GND	JUNCTION BOX CONNECTION
ZP-109-2A	TELECOM RACK RECEPTACLE	-	-	10500	-	208	3	N/A	UPS-A-2,4,6	1.25" C, 3#4, 1#3 NEUT, 1#10 GND	JUNCTION BOX CONNECTION
ZP-109-2B	TELECOM RACK RECEPTACLE	-	-	10500	-	208	3	N/A	UPS-B-2,4,6	1.25" C, 3#4, 1#3 NEUT, 1#10 GND	JUNCTION BOX CONNECTION
ZP-109-3A	TELECOM RACK RECEPTACLE	-	-	10500	-	208	3	N/A	UPS-A-7,9,11	1.25" C, 3#4, 1#3 NEUT, 1#10 GND	JUNCTION BOX CONNECTION
ZP-109-3B	TELECOM RACK RECEPTACLE	-	-	10500	-	208	3	N/A	UPS-B-7,9,11	1.25" C, 3#4, 1#3 NEUT, 1#10 GND	JUNCTION BOX CONNECTION
ZP-109-4A	TELECOM RACK RECEPTACLE	-	-	10500	-	208	3	N/A	UPS-A-8,10,12	1.25" C, 3#4, 1#3 NEUT, 1#10 GND	JUNCTION BOX CONNECTION
ZP-109-4B	TELECOM RACK RECEPTACLE	-	-	10500	-	208	3	N/A	UPS-B-8,10,12	1.25" C, 3#4, 1#3 NEUT, 1#10 GND	JUNCTION BOX CONNECTION
RK-109-5A	TELECOM RACK RECEPTACLE	-	-	3500	-	208	3	N/A	UPS-A-13,15,17	0.75" C, 3#10, 1#8 NEUT, 1#10 GND	PROVIDE NEMA L21-20R, SEE 5/0000-1-001
RK-109-5B	TELECOM RACK RECEPTACLE	-	-	3500	-	208	3	N/A	UPS-B-13,15,17	0.75" C, 3#10, 1#8 NEUT, 1#10 GND	PROVIDE NEMA L21-20R, SEE 5/0000-1-001
RK-109-6A	TELECOM RACK RECEPTACLE	-	-	3500	-	208	3	N/A	UPS-A-14,16,18	0.75" C, 3#10, 1#8 NEUT, 1#10 GND	PROVIDE NEMA L21-20R, SEE 5/0000-1-001
RK-109-6B	TELECOM RACK RECEPTACLE	-	-	3500	-	208	3	N/A	UPS-B-14,16,18	0.75" C, 3#10, 1#8 NEUT, 1#10 GND	PROVIDE NEMA L21-20R, SEE 5/0000-1-001
ZP-109-7A	TELECOM RACK RECEPTACLE	-	-	10500	-	208	3	N/A	UPS-A-19,21,23	1.25" C, 3#4, 1#3 NEUT, 1#10 GND	JUNCTION BOX CONNECTION
ZP-109-7B	TELECOM RACK RECEPTACLE	-	-	10500	-	208	3	N/A	UPS-B-19,21,23	1.25" C, 3#4, 1#3 NEUT, 1#10 GND	JUNCTION BOX CONNECTION
ZP-109-8A	TELECOM RACK RECEPTACLE	-	-	10500	-	208	3	N/A	UPS-A-20,22,24	1.25" C, 3#4, 1#3 NEUT, 1#10 GND	JUNCTION BOX CONNECTION
ZP-109-8B	TELECOM RACK RECEPTACLE	-	-	10500	-	208	3	N/A	UPS-B-A-20,22,24	1.25" C, 3#4, 1#3 NEUT, 1#10 GND	JUNCTION BOX CONNECTION
65-REC-1	CONVENIENCE RECEPTACLE	-	-	-	180	120	1	N/A	XXXXXXX	0.75" C, 2#12, 1#12 GND	PROVIDE GFCI, WEATHERPROOF CONVENIENCE RECEPTACLE

SITE LEGEND

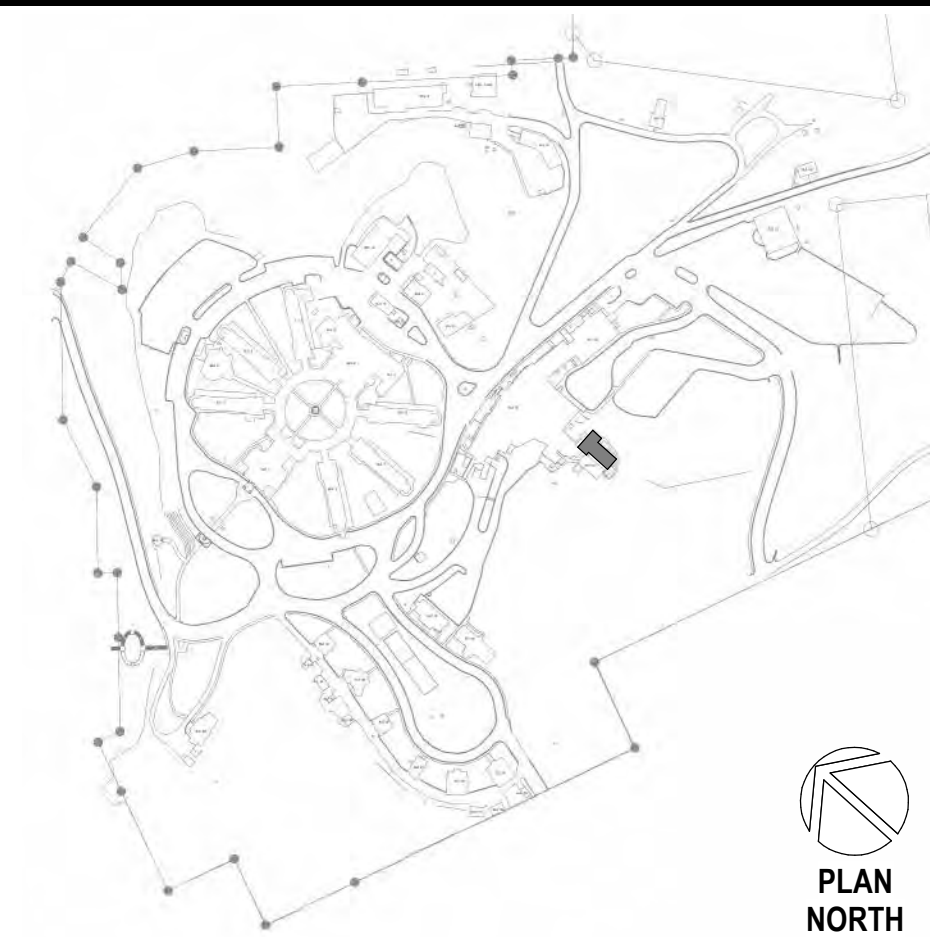

1 ELECTRICAL REMODEL PLAN - BLDG 65
1/4" = 1'-0"



Revisions:	Date:

CONSULTANT

A/E:
GDM
1000 W STEUBEN ST. UNIT 3
BINGEN, WA 98605
541.436.4723
ADAM GOODIN, PE

ARCHITECT/ENGINEER OF RECORD

MECHANICAL AND ELECTRICAL CONSULTING ENGINEERS
670 West Firerweed Lane, Suite 200
Anchorage, AK 99503
Phone (907) 278-0521
Corporate No.: AEC0542

STAMP

PROGRAM CONTRACTING ACTIVITY CENTRAL (PCAC)

U.S. Department of Veterans Affairs

DRAWING TITLE

ELECTRICAL REMODEL PLAN - BLDG 65

APPROVED: Project Director

PHASE

100% CD

FLS

FULLY SPRINKLERED

PROJECT TITLE

EHRM INFRASTRUCTURE UPGRADES

LOCATION
HOT SPRINGS, SOUTH DAKOTA

ISSUE DATE
02/22/2022

CHECKED BY
JAM

DRAWN BY
NVF

PROJECT NUMBER
568A4-21-702

BUILDING NUMBER
65

DRAWING NUMBER
065-EP-011


GENERAL NOTES:

- A. SEE SHEET 065-EP-011 FOR GENERAL NOTES.
- B. SEE EQUIPMENT SCHEDULE ON SHEET 065-EP-011 FOR POWER REQUIREMENTS.

SHEET NOTES:

1. REMODEL, INCLUDING PHASING, SHALL BE COORDINATED TO MINIMIZE DISRUPTION AND DOWNTIME TO MCR.
2. PROVIDE BUS A/BUS B DISTRIBUTION FROM UPS A/UPS B.
3. NEW 100KVA UPS. PROVIDE FEEDER TO BLDG 12 DISTRIBUTION SYSETM SEE ONE-LINE DIAGRAM 1/EK-103.
4. NEW UPS A INSTALLED AFTER UPS B IS ACTIVE.
5. CONNECT TO SHUNT TRIP BREAKERS OF UPS FEEDER CIRCUITS. SEE ONE-LINE 1/EK-103.
6. PROVIDE NEW POWER DISTRIBUTION UNDER FLOOR.
7. EXTEND AND RECONNECT EXISTING MECHANICAL CIRCUITS TO NEW MECHANICAL EQUIPMENT.
8. PROVIDE CIRCUIT FOR FIRE/SMOKE DAMPER. PROVIDE CONNECTION TO FIRE ALARM SYSTEM FOR SHUTDOWN UPON ALARM.
9. GASEOUS SUPPRESSION SYSTEM SHALL BE INSTALLED HERE. SEE FIRE PROTECTION DRAWINGS. PROVIDE DEDICATED CIRCUITS AS REQUIRED FOR EQUIPMENT.

SITE LEGEND

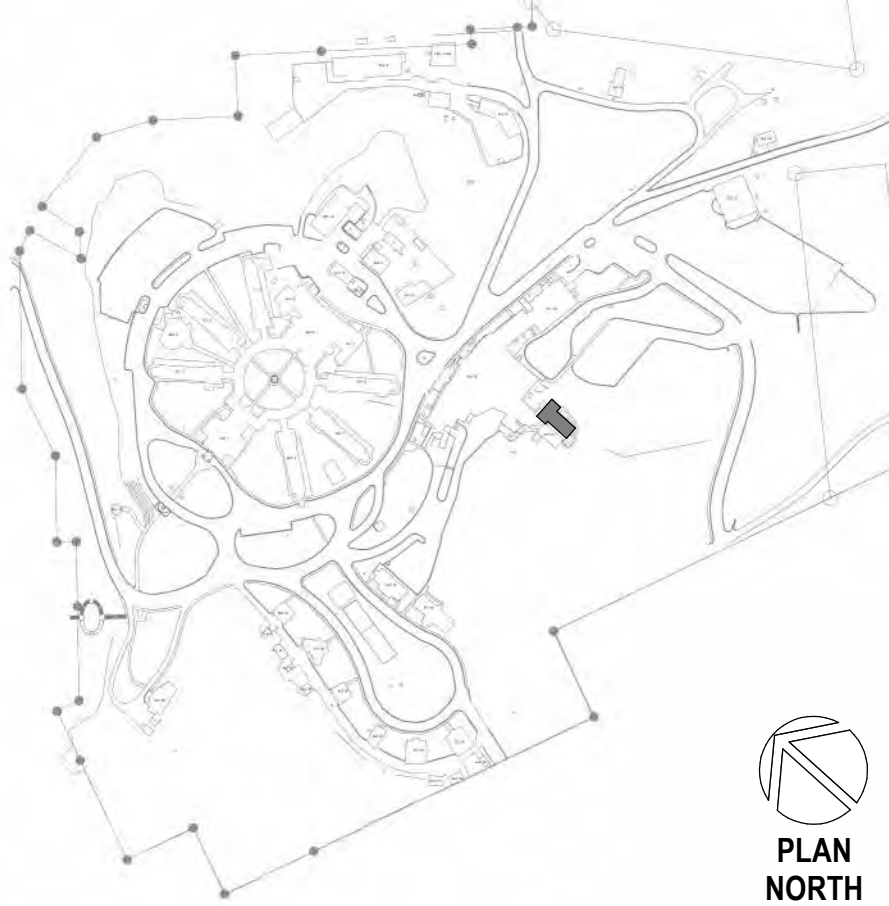

1 ENLARGED ROOM - 109 ELECTRICAL REMODEL

1/2" = 1'-0"

2/22/2022 5:46:16 PM

C:\Users\jly\Angen\Documents\20\Local\MT121\ESERIES-BLDG 05_201\angenh71605.rvt

Revisions:	Date:

CONSULTANT

A/E:
GDM
1000 W STEUBEN ST. UNIT 3
BINGEN, WA 98605
541.436.4723
ADAM GOODIN, PE

GDM
ARCHITECTS • ENGINEERS

ARCHITECT/ENGINEER OF RECORD

RSA
Engineering, Inc.
MECHANICAL AND ELECTRICAL CONSULTING ENGINEERS
670 West Firweed Lane, Suite 200
Anchorage, AK 99503
Phone (907) 278-0521
Corporate No.: AEC0542

STAMP

STATE OF ALASKA
JEREMY A. MAXIE
EE-113847
REGISTERED PROFESSIONAL ENGINEER

PROGRAM
CONTRACTING
ACTIVITY
CENTRAL (PCAC)

VA U.S. Department
of Veterans Affairs

DRAWING TITLE

ENLARGED ELECTRICAL
REMODEL PLAN - ROOM 109

APPROVED: Project Director

PHASE

100% CD

FLS

FULLY SPRINKLERED

PROJECT TITLE

EHRM INFRASTRUCTURE
UPGRADES

LOCATION

HOT SPRINGS, SOUTH DAKOTA

ISSUE DATE

02/22/2022

CHECKED BY

JAM

DRAWN BY

NVF

PROJECT NUMBER

568A4-21-702

BUILDING NUMBER

65

DRAWING NUMBER

065-EP-012

VA FORM 08 - 6231



PROJECT TITLE EHRM INFRASTRUCTURE UPGRADES			PROJECT NUMBER 568A4-21-702		
LOCATION HOT SPRINGS, SOUTH DAKOTA			BUILDING NUMBER 65		
			DRAWING NUMBER 065-EP-012.1		
ISSUE DATE 02/22/2022		CHECKED BY JAM		DRAWN BY CK	

A

B

C

D

E

F

A

B

C

D



E

F

2/22/2022 5:46:17 PM

C:\Users\JLlynn\Angwin\Documents\2020\Local\MT121\ESERIES-BLDG 65_201\angwin071665.rvt

1 ENLARGED ROOM - 109 LIGHTING REMODEL
1/2" = 1'-0"

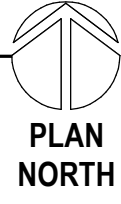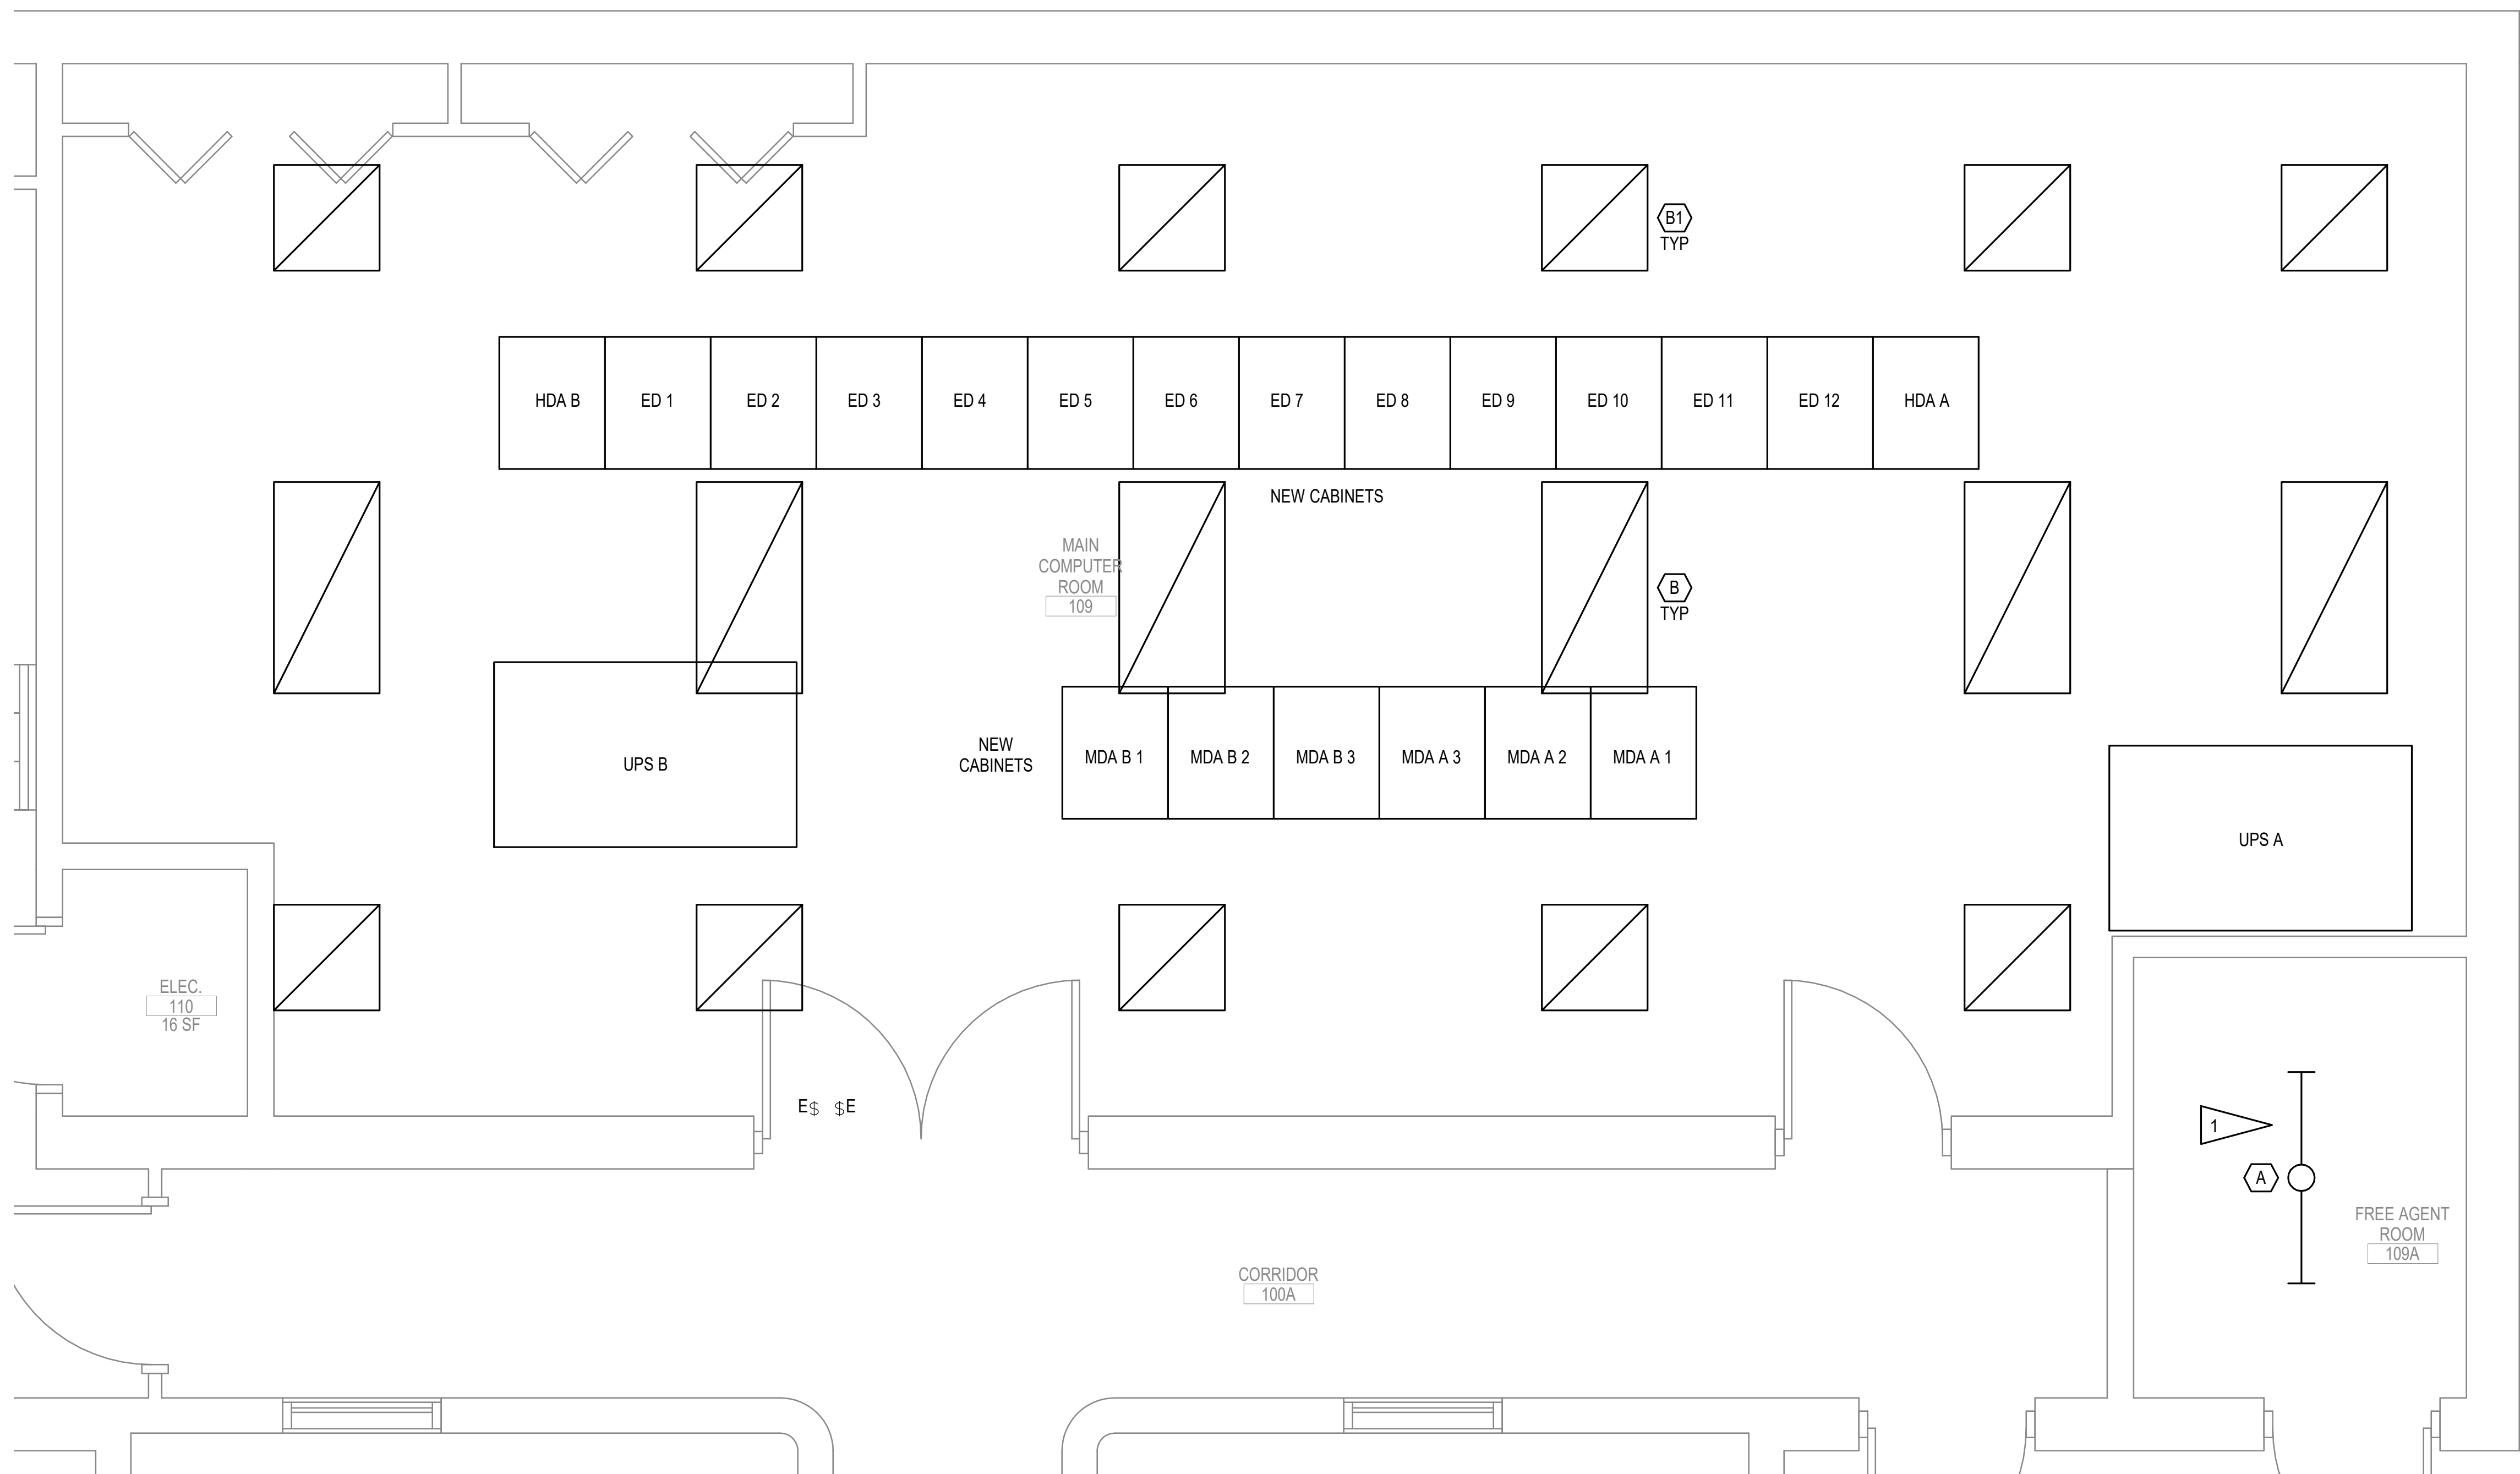


GENERAL NOTES:

- A. SEE SHEET 065-EP-011 FOR GENERAL NOTES.
- B. CONNECT LIGHTING TO EXISTING CIRCUIT. EXTEND CONDUIT AND CONDUCTORS TO NEW LOCATIONS.
- C. SWITCHING SHALL REMAIN FOR NEW FIXTURES.
- D. EXISTING FIXTURE CIRCUIT IS CONNECTED TO EMERGENCY EQUIPMENT BRANCH OF THE EXISTING DISTRIBUTION SYSTEM.

SHEET NOTES:

- 1. CONNECT TO EXISTING LIGHTING CIRCUIT IN ROOM 109. EXTEND CONDUIT AND CONDUCTORS AS NECESSARY.

SITE LEGEND

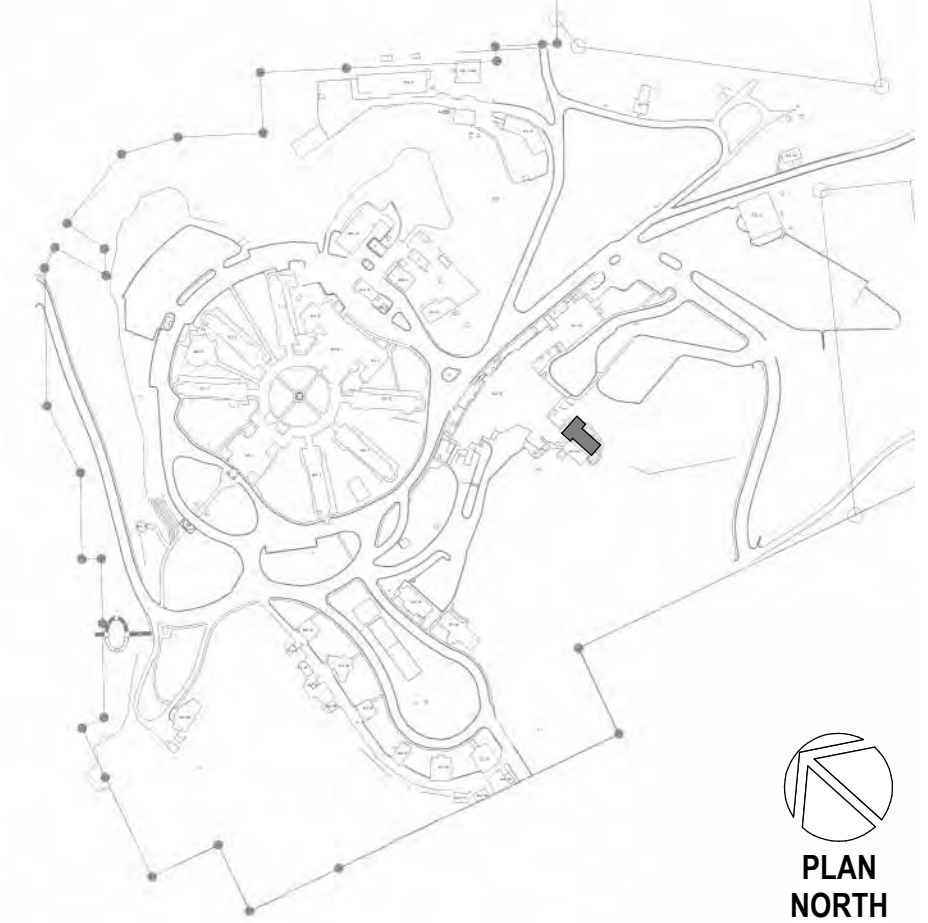

<table><tr><td>Revisions:</td><td>Date:</td></tr><tr><td> </td><td> </td></tr><tr><td> </td><td> </td></tr><tr><td> </td><td> </td></tr><tr><td> </td><td> </td></tr><tr><td> </td><td> </td></tr><tr><td> </td><td> </td></tr><tr><td> </td><td> </td></tr></table>		Revisions:	Date:															CONSULTANT A/E: GDM 1000 W STEUBEN ST. UNIT 3 BINGEN, WA 98605 541.436.4723 ADAM GOODIN, PE GDM ARCHITECTS • ENGINEERS	ARCHITECT/ENGINEER OF RECORD RSA Engineering, Inc. MECHANICAL AND ELECTRICAL CONSULTING ENGINEERS 670 West Fireweed Lane, Suite 200 Anchorage, AK 99503 Phone (907) 276-0521 Corporate No.: AECC542	STAMP STATE OF ALASKA 4016 113847 JEREMY A. MAXIE MECHANICAL AND ELECTRICAL ENGINEERING REGISTERED PROFESSIONAL	PROGRAM CONTRACTING ACTIVITY CENTRAL (PCAC) VA U.S. Department of Veterans Affairs	DRAWING TITLE ENLARGED LIGHTING REMODEL PLAN - ROOM 109 APPROVED: Project Director	PHASE 100% CD FLS FULLY SPRINKLERED	PROJECT TITLE EHRM INFRASTRUCTURE UPGRADES LOCATION HOT SPRINGS, SOUTH DAKOTA ISSUE DATE 02/22/2022 CHECKED BY JAM DRAWN BY NVF	PROJECT NUMBER 568A4-21-702 BUILDING NUMBER 65 DRAWING NUMBER 065-EP-013
Revisions:	Date:																								

