




EQUIP. NUMBER	DESCRIPTION	VOLTAGE	PHASE	AMPS	VA	TYPE	RECEPTACLE
F2700	BAR CODE READER	120V	1		200VA	PLUG	NEMA 5-20R
M1801	COMPUTER WITH FLAT PANEL MONITOR	120V	1		300VA	PLUG	NEMA 5-20R
M1803	WALL MOUNTED COMPUTER WORKSTATION	120V	1		300VA	PLUG	NEMA 5-20R
M3160	MEDIVATOR	120V	1	0.7A	85VA	PLUG	NEMA 5-20R
R7250	REFRIGERATOR	120V	1		800VA	PLUG	NEMA 5-20R
S0002	READER 390	120V	1		200VA	PLUG	NEMA 5-20R
S0003	SCANNER CHARGING STATION	120V	1		600VA	PLUG	NEMA 5-20R
S0004	INCUBATOR	120V	1		500VA	PLUG	NEMA 5-20R
S0005	BATTERY CHARGING STATION	120V	1		500VA	PLUG	NEMA 5-20R
S0007	ULTRASONIC CLEANER	120V	1		1000VA	PLUG	NEMA 5-20R
S0046	STERIS AMSCO DRYING CABINET	120V	1		1500VA	PLUG	NEMA 5-20R
S0442	AMSCO 600 STEAM STERILIZER	480V	3	7A	5820VA	E-CONN.	
S0940	STERIS AMSCO 7052HP WASHER / DISINFECTOR	480V	3	34.5A	28682VA	E-CONN.	
S0941	STERIS WASHER / DISINFECTOR CONVEYOR SYSTEM	120V	1	12.5A	1500VA	PLUG	NEMA 5-20R
S0942	STERIS MOTORIZED RETURN CONVEYOR SYSTEM WITH DOOR	120V	1	12.5A	1500VA	PLUG	NEMA 5-20R
S1905	STERIS AUTOMATED PASS THROUGH WINDOW 34"x45"	120V	1	1A	120VA	PLUG	NEMA 5-20R
S2627	ADVANTAGE PLUS PASS-THRU ENDOSCOPE REPROCESSOR	120V	1	10A	1200VA	PLUG	NEMA 5-20R
S2635	INNOVAVE ULTRASONIC IRRIGATOR & CLEANER	208V	3	15A	5403VA	PLUG	NEMA L15-20R
S3185	STERIS VISION 1327 CART AND UTENSIL WASHER	480V	3	13.5A	11224VA	E-CONN.	
S5505	STERIS AMSCO V-PRO MAX LOW TEMP STERILIZER	208V	3	16A	5764VA	PLUG	NEMA L15-20R
S9610	AMSCO PREP AND PACK WORK STATION 36" X 72" (ELECTRIC)	120V	1	15A	1800VA	PLUG	NEMA 5-20R

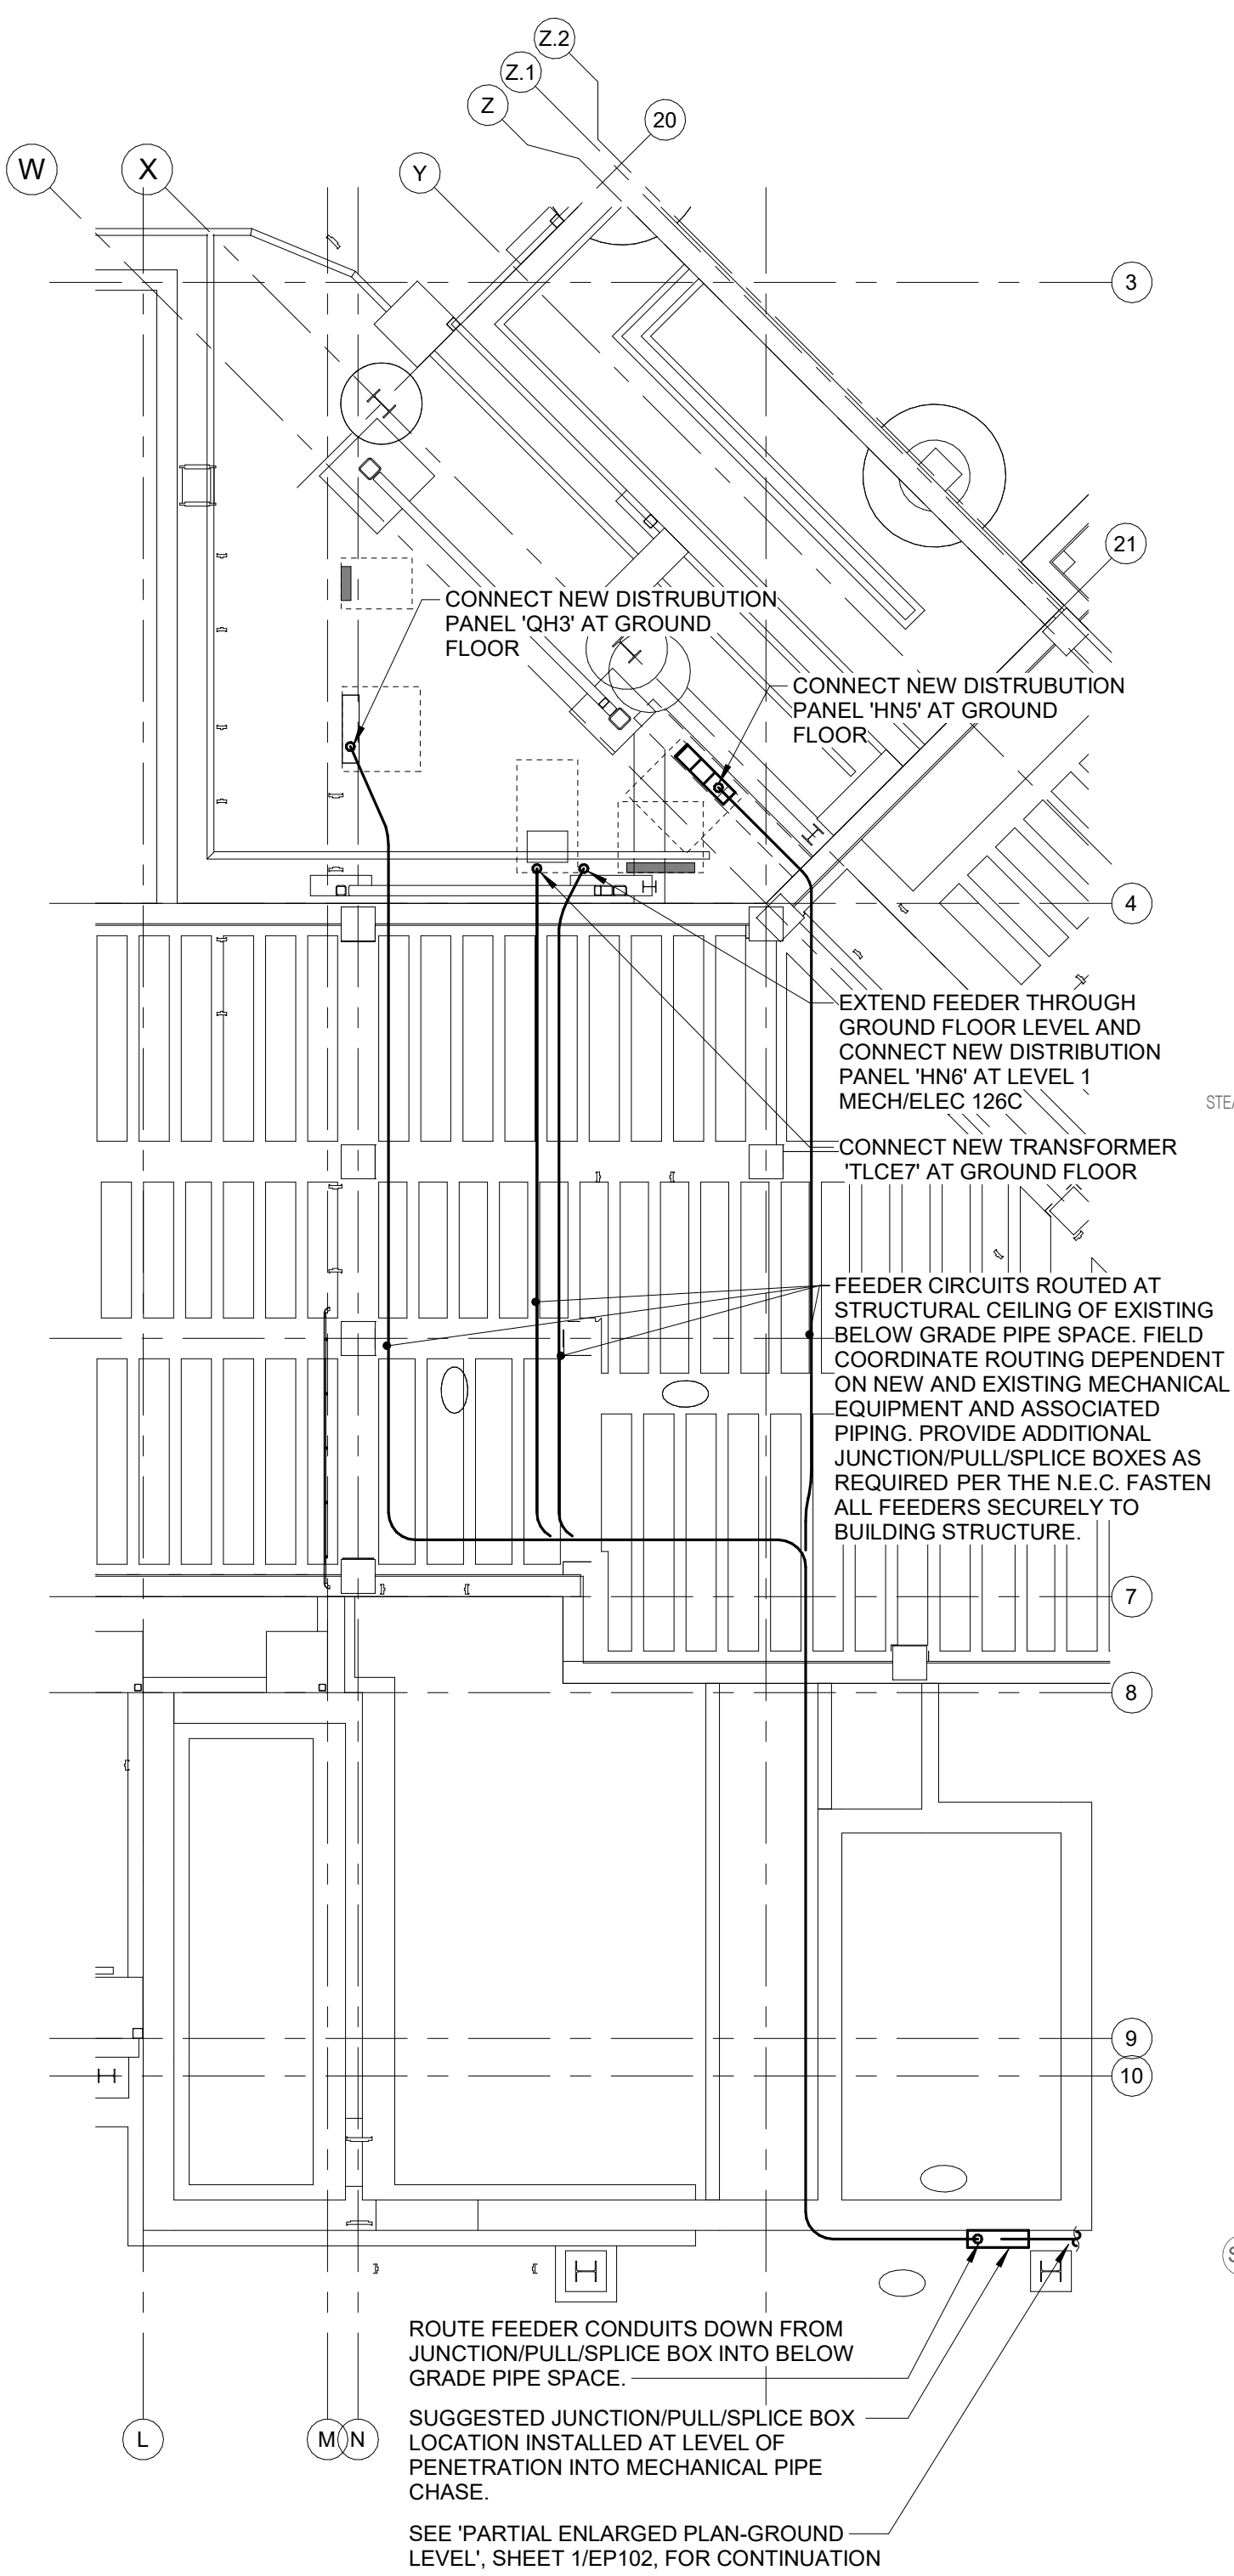

3 PIPE BASEMENT FLOOR PLAN - POWER
1/8" = 1'-0"

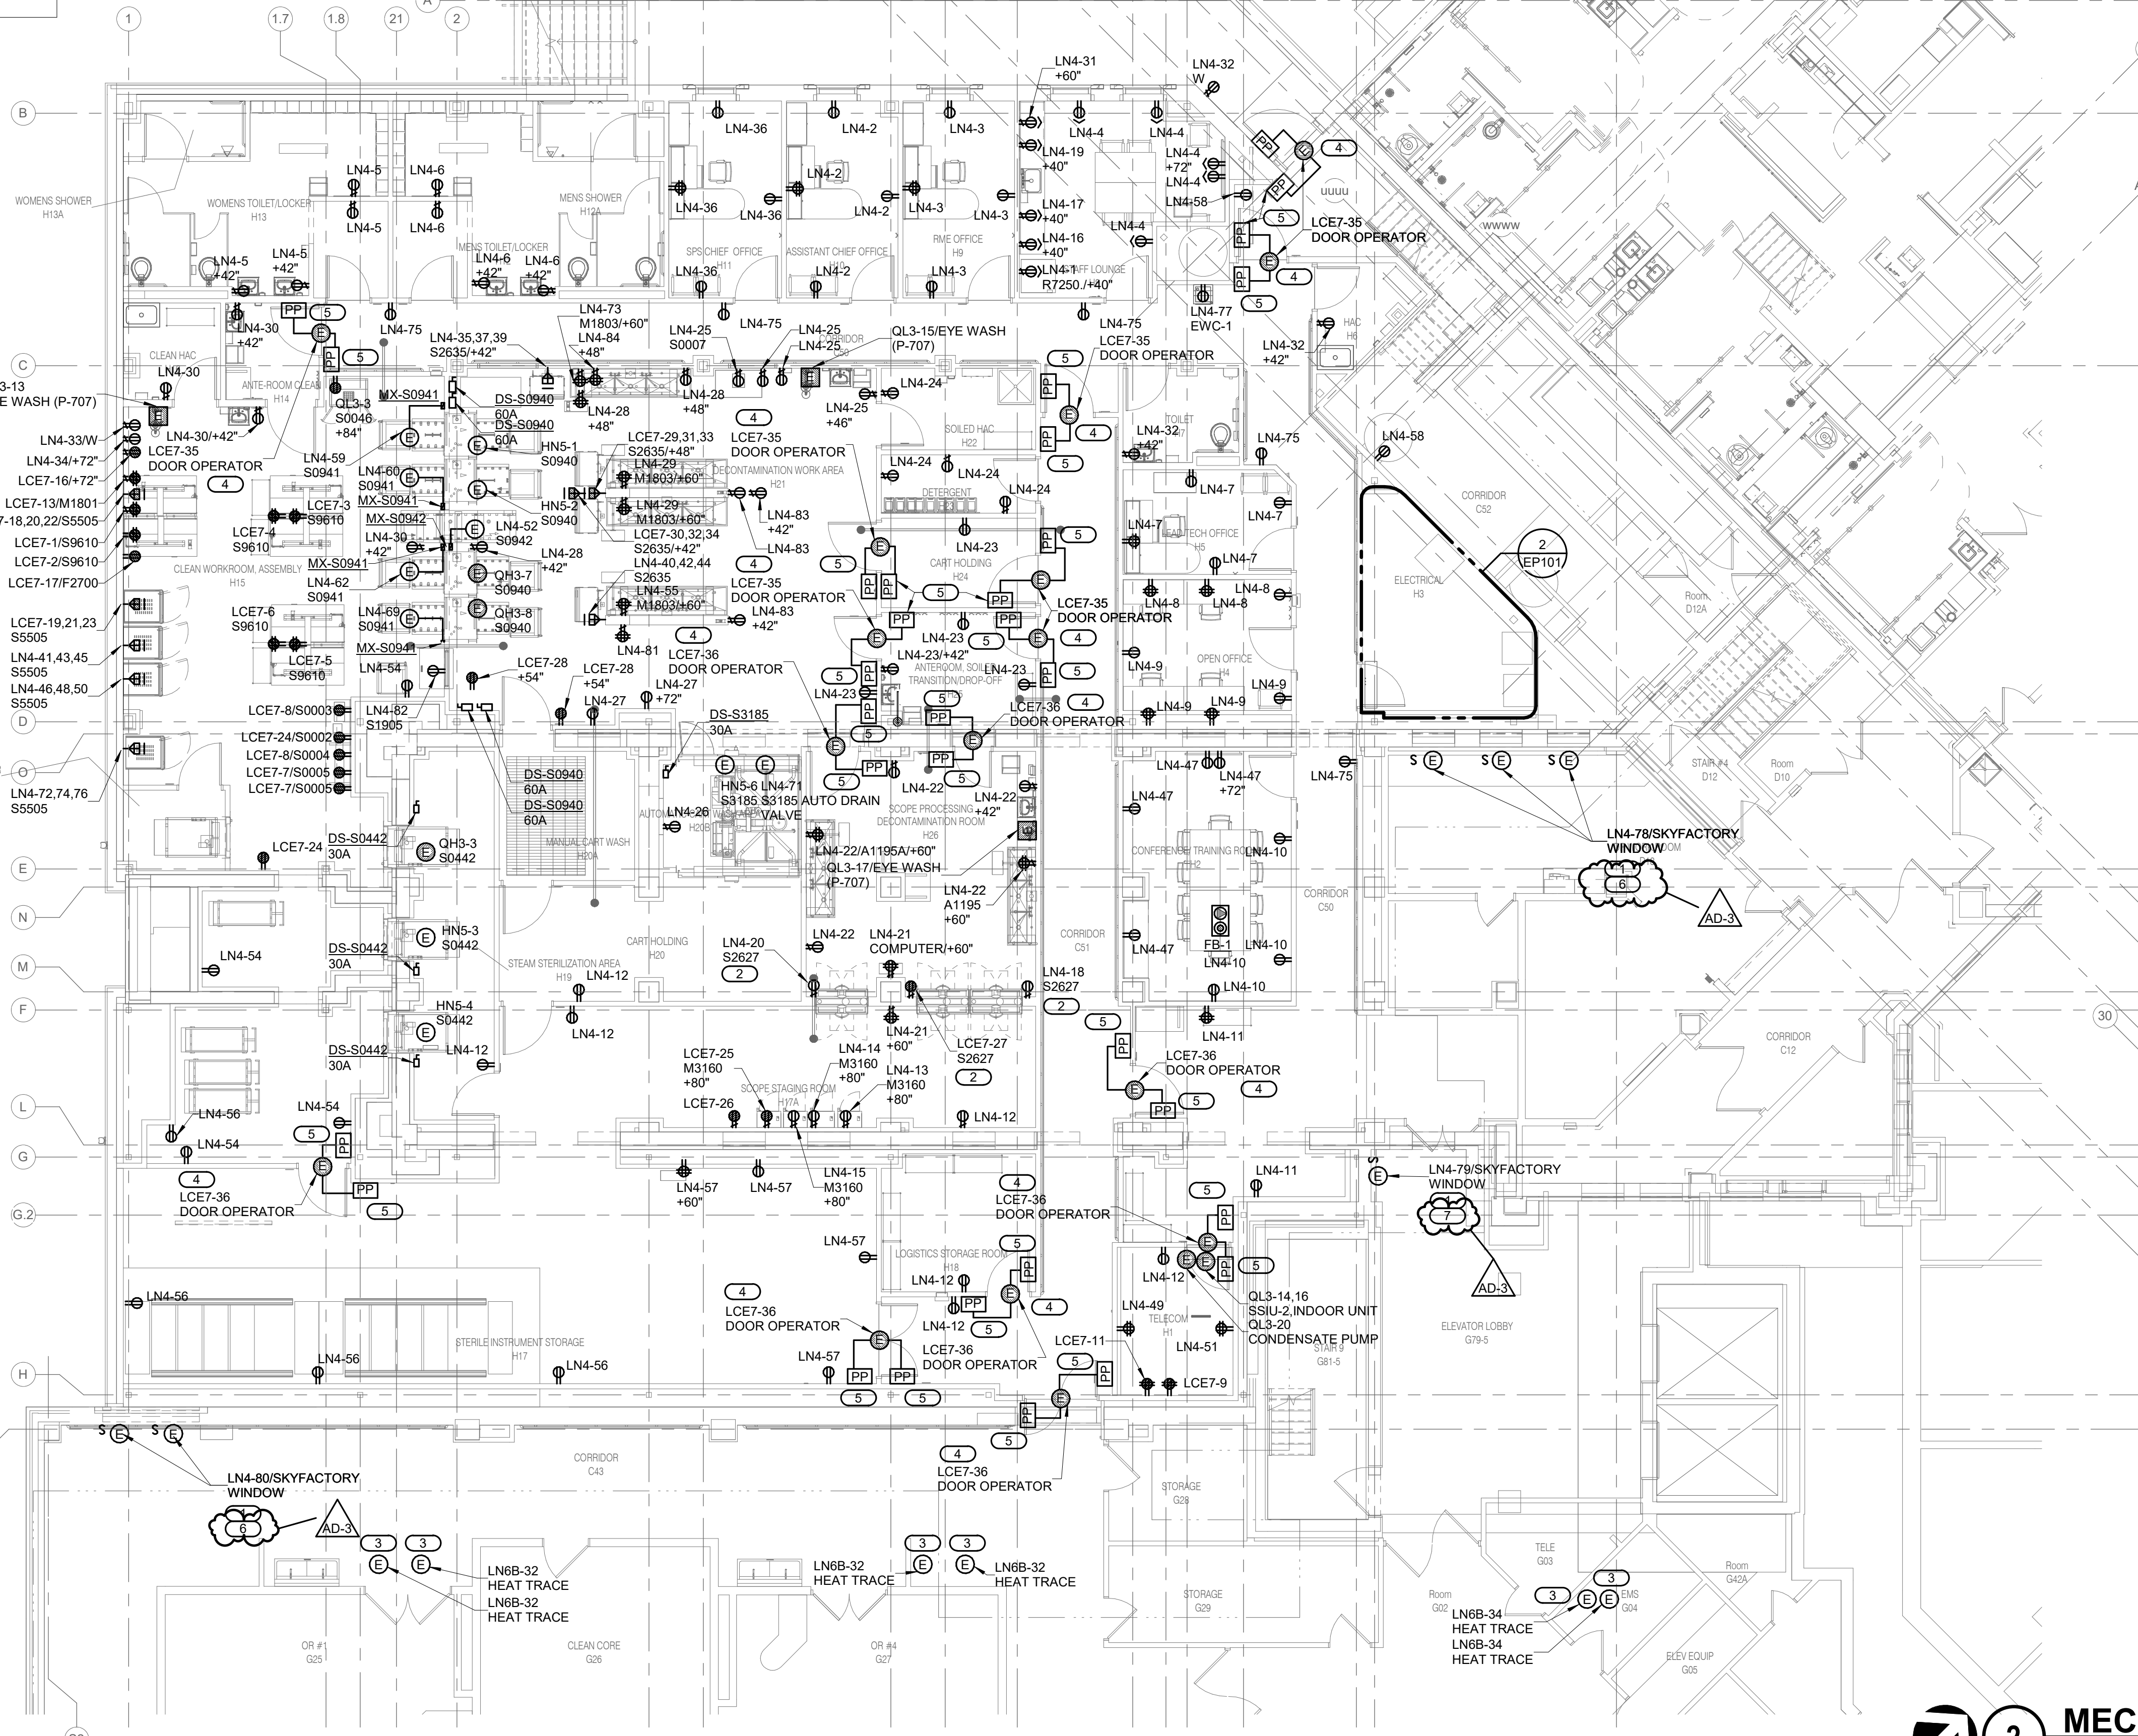

1 GROUND LEVEL FLOOR PLAN - POWER
1/8" = 1'-0"

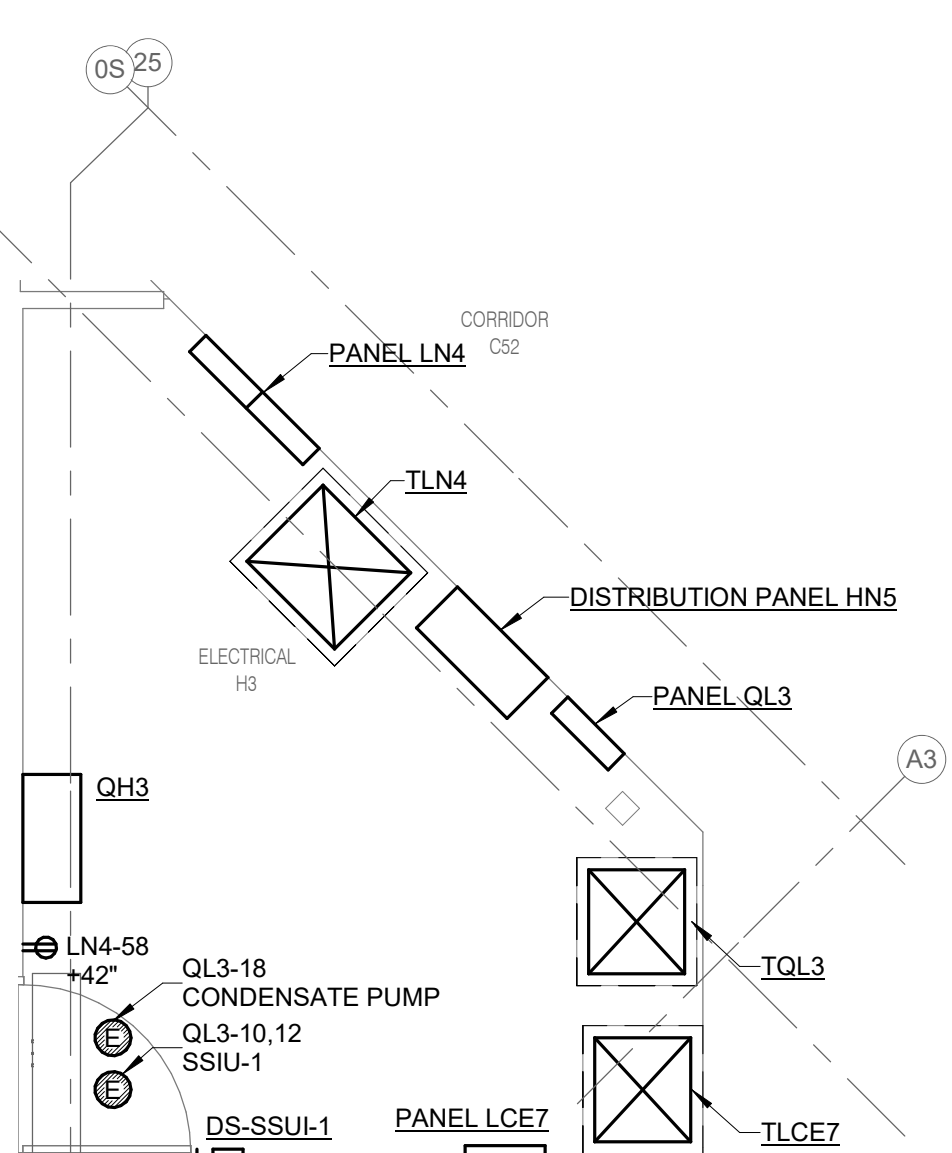

2 MECHANICAL/ELECTRICAL ROOM - POWER
1/4" = 1'-0"

Addendum 3 (AD-3) Revisions:		05/20/2025 Date:	
CONSULTANT IMEG 2802 10TH STREET DES MOINES, IA 50325 515.334.9900 FAX: 515.334.9988 www.imegcorp.com PROJECT # 19004249.04		ARCHITECT/ENGINEER OF RECORD ANDERSON 13605 1st Ave. N. #100 Plymouth, MN 55441 P 763.412.4000 F 763.412.4090 ae-mn.com Anderson Engineering of Minnesota, LLC Proj # 16584	
Office of Construction and Facilities Management U.S. Department of Veterans Affairs		Drawing Title GROUND LEVEL FLOOR PLAN - POWER Approved:	
Phase BID DOCUMENTS		Project Title CONSTRUCT NEW SPS	
FULLY SPRINKLERED		Location Sioux Falls, SD.	
Issue Date 07/17/2024		Checked JMK	
Drawn JDR		Project Number 438-460 Building Number 5 Drawing Number EP101	